
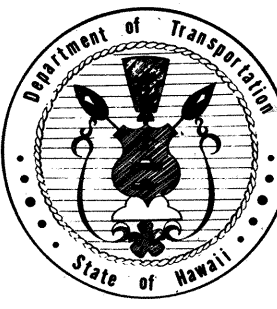




INDEX TO DRAWINGS	
SHEET NO.	DESCRIPTION
1	TITLE SHEET
2-4	TYPICAL SECTIONS
5-15	ROADWAY PLAN
16-17	PAVEMENT GRADE PLAN
18-19	UTILITY PLANS
20-48	MISC. & STANDARD DETAILS
49-87	DRAINAGE & SPRINKLER PLAN & DETAILS
88-128	SIGNING, MARKING PLAN & DETAILS
129-149	HIGHWAY LIGHTING
150-180	KALIHI STREAM BRIDGE WIDENING, RETAINING WALLS, GUARD RAIL CONNECTIONS & DETAILS
181-197	CROSS SECTIONS

① C.O. 34 S-1, C.O. 36 S-1, ADD 48 S-1
 ② ADD 79 S-1 ARE SUPPLEMENT SHEETS TO THE CONTRACT PLANS
 TOTAL = 201 SHEETS

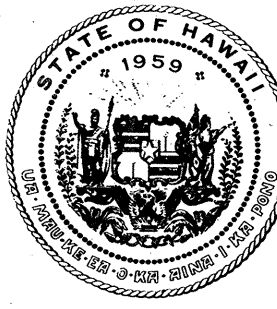

STATE OF HAWAII
 DEPARTMENT OF TRANSPORTATION
 HIGHWAYS DIVISION
 HONOLULU, HAWAII
 "AS-BUILT"
 PLANS FOR
 INTERSTATE ROUTE H-1 IMPROVEMENTS
 MIDDLE STREET TO KALIHI INTERCHANGE
 WESTBOUND LANES
 FEDERAL AID INTERSTATE PROJECT NO. I-HI-1(187)
 DISTRICT OF HONOLULU
 ISLAND OF OAHU

FED. ROAD DIST. NO.	STATE	FED. AID PROJ. NO.	FISCAL YEAR	SHEET NO.	TOTAL SHEETS
HAWAII	HAW.	I-HI-1(187)	1984	1	197

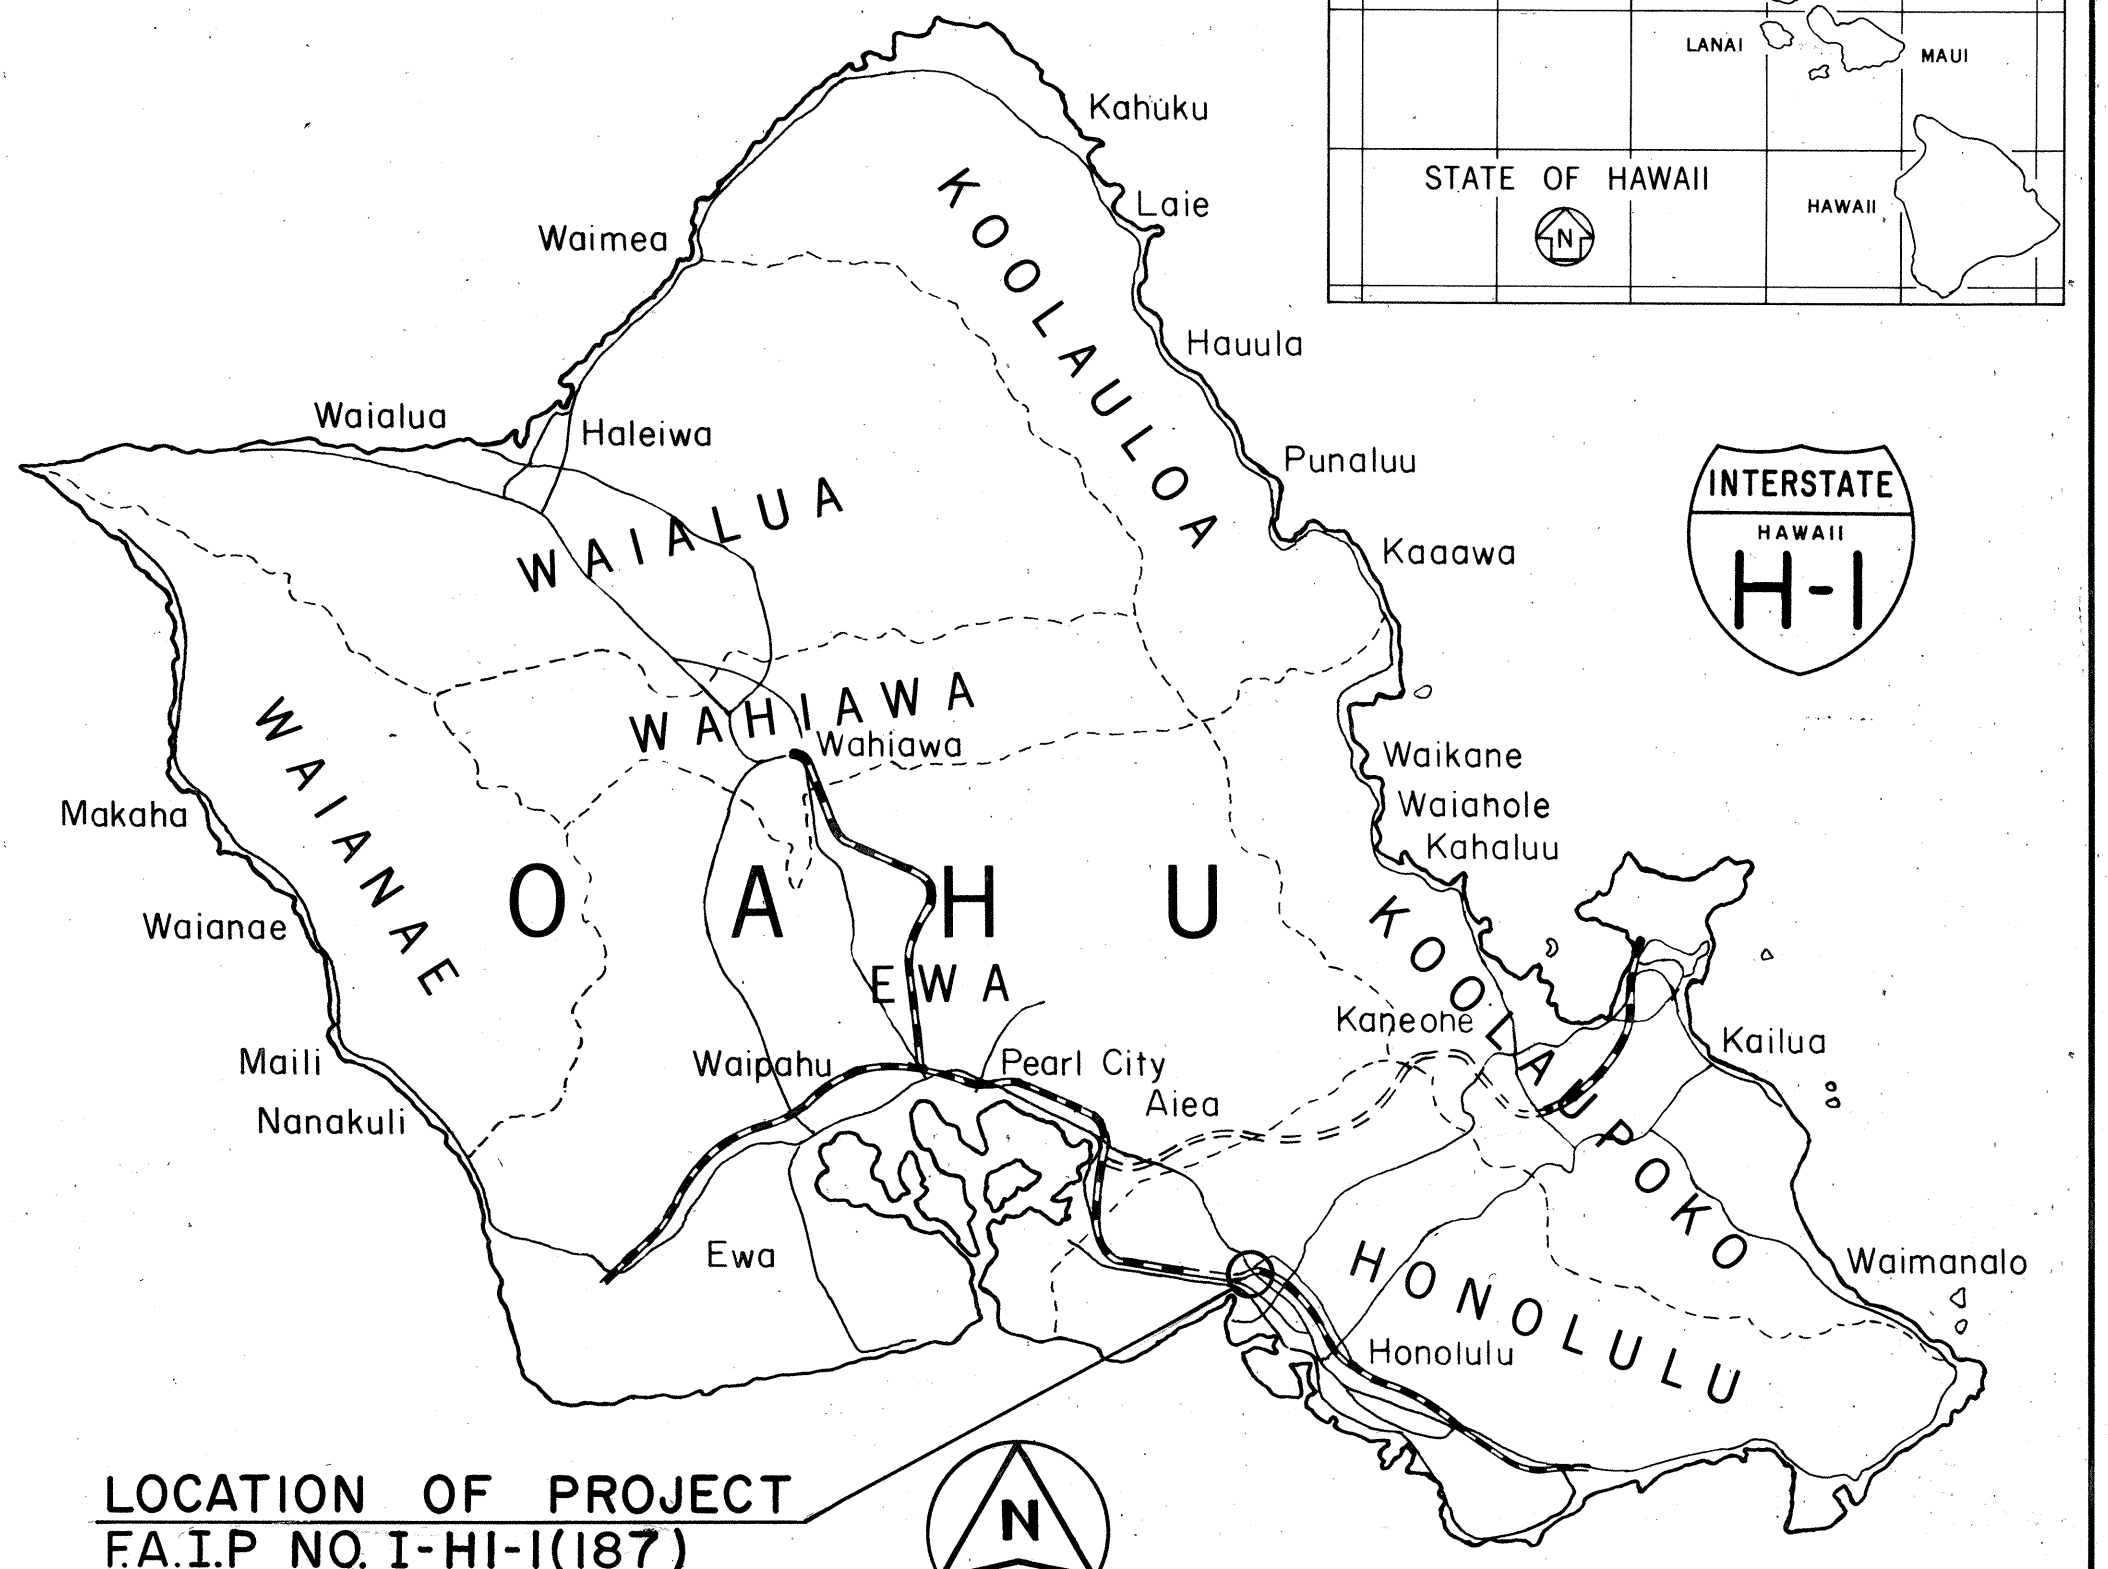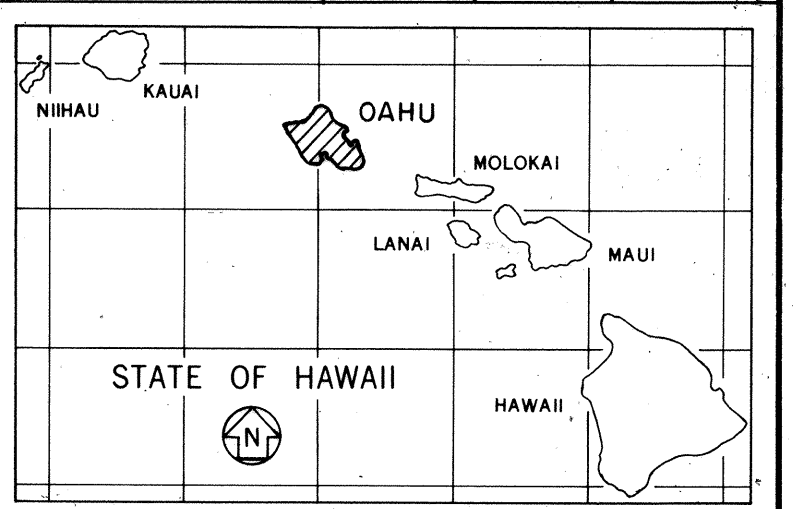

LOCATION OF PROJECT
 F.A.I.P. NO. I-HI-1(187)
 SCALE IN MILES
 4 0 4 8

— FEDERAL AID INTERSTATE PROJECTS PREVIOUSLY CONSTRUCTED OR UNDER CONSTRUCTION

CHANGES MADE DURING CONSTRUCTION HAVE BEEN INCORPORATED ON THESE PLANS EXCEPT CHANGES IN THE ORIGINAL THEORETICAL QUANTITIES. FOR ACTUAL QUANTITIES, REFER TO PROJECT LEDGER AND/OR COMPUTATION BOOK.


Michael Dwyer 12/5/88
 RESIDENT ENGINEER DATE

DESIGN CLASSIFICATION

ADT (1983) 140,995
 ADT (2003) 154,990
 DHV 12,403
 T24 3.0%
 V 50 MPH

DEPARTMENT OF TRANSPORTATION
 FEDERAL HIGHWAY ADMINISTRATION
 APPROVED: *W. L. L. L.* 9/28/83
 DIVISION ADMINISTRATOR DATE

DEPARTMENT OF TRANSPORTATION
 STATE OF HAWAII
 APPROVED: *R. Higashimura* Sep 23 83
 DIR. OF TRANSPORTATION DATE

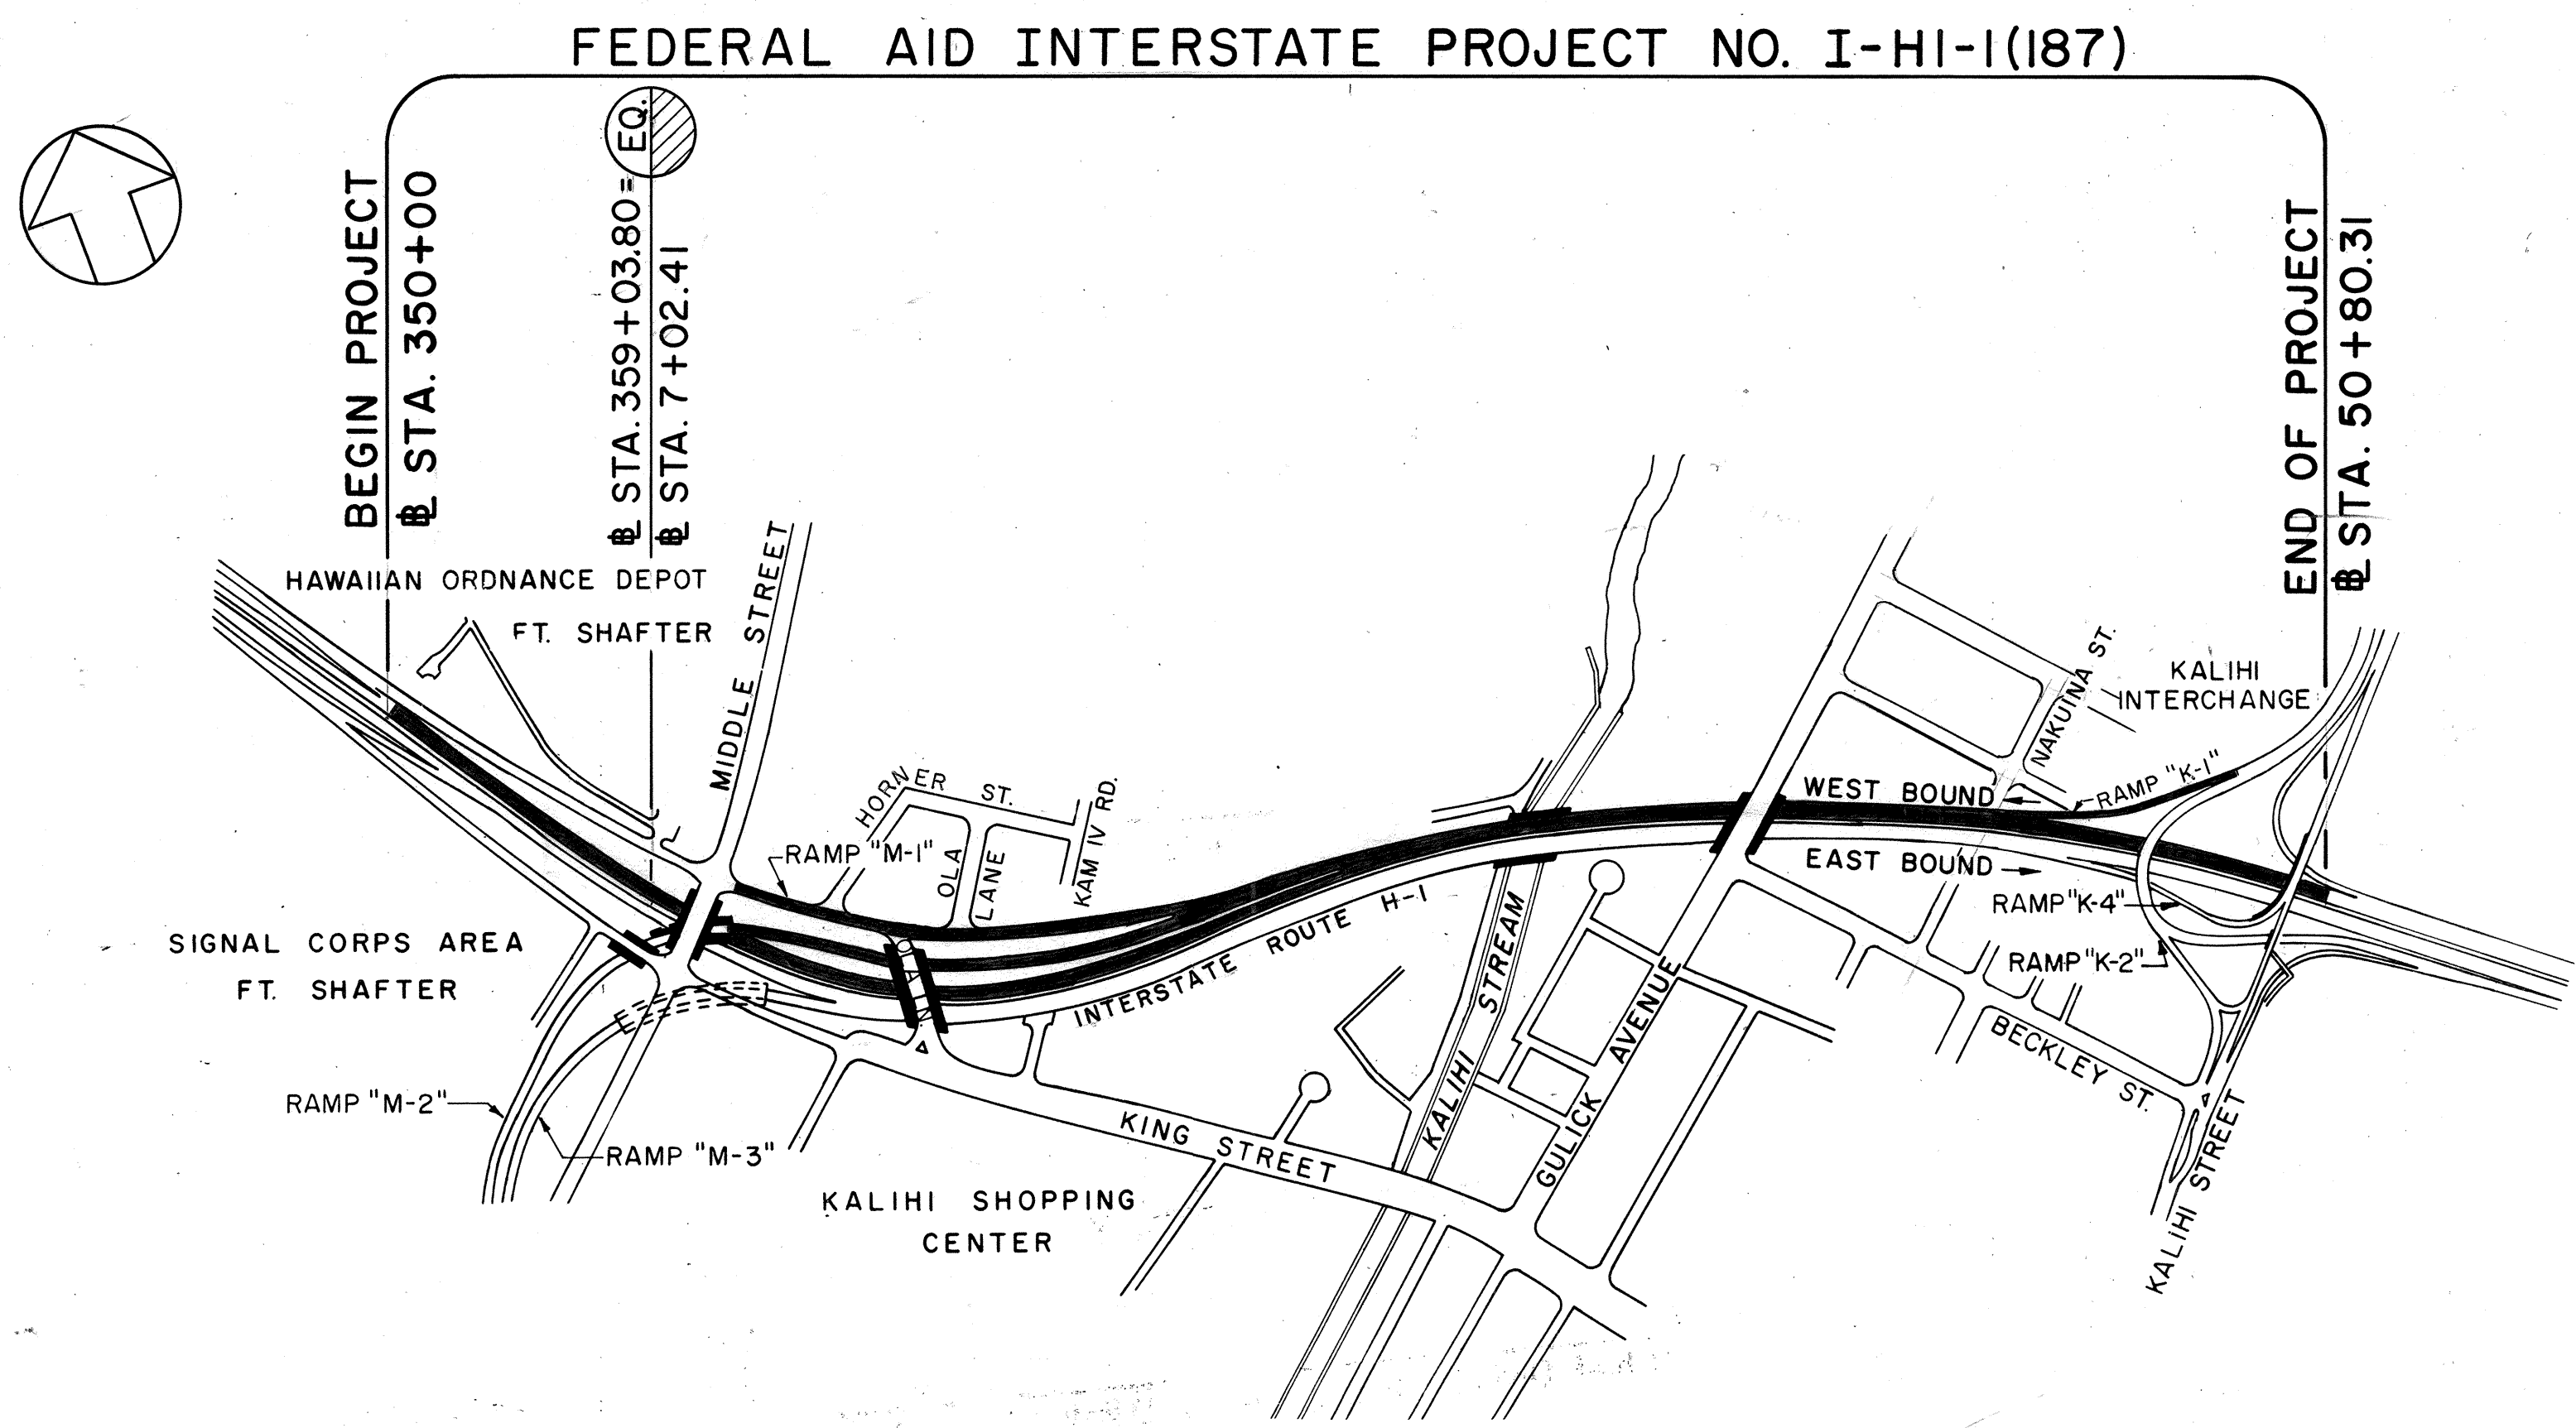

LAYOUT PLAN
 LENGTH OF PROJECT 1.000 MILE
 GRAPHIC SCALE
 400 0 400 600 1200

DESIGN UNIT "E" A. YAMAGUCHI 548-4125 June, 1983
 DESIGNED BY P. S. & E. BY PHONE DATE