

INDEX TO DRAWINGS	
SHEET NO.	DESCRIPTION
1	TITLE SHEET
2	CONSTRUCTION PHASING
3-4	TYPICAL SECTIONS
5-II	ALIGNMENT PLANS
12-14	ROADWAY PROFILES & SUPERELEVATION DIAGRAMS
15-24	ROADWAY CONSTRUCTION PLANS & DETAILS
25-43	DRAINAGE AND GRADING PLANS & DETAILS
44	EROSION CONTROL NOTES & DETAILS
45-71, 71A, 72-83	SIGNING AND PAVEMENT MARKING PLANS & DETAILS
84-99	HIGHWAY LIGHTING PLANS & DETAILS
100-101	EXISTING UTILITIES
102-115	BORING LOCATION PLAN & LOGS
116-160	H-1 (EB) VIADUCT
161-176	STRUCTURAL STANDARD DETAILS
177-195	CROSS SECTIONS
196-210	SUPPLEMENTAL PLANS FOR AIRPORT INTERCHANGE

- ①

I7S-1
- ②

C.O. 54S-1
- ③

C.O. 203S-1, ADD. 210S-1 - ADD. 210S-10
- THESE ARE SUPPLEMENTAL SHEETS TO THE CONTRACT PLANS.

NEW TOTAL = 224

STATE OF HAWAII

DEPARTMENT OF TRANSPORTATION

HIGHWAYS DIVISION

HONOLULU, HAWAII

"AS-BUILT"

PLANS FOR

CONSTRUCTION OF A PORTION OF

INTERSTATE ROUTE H-1


KEEHI INTERCHANGE

LAGOON DRIVE TO AHUA STREET

FEDERAL AID INTERSTATE PROJECT NO. I-IR-HI-1(170):17

DISTRICT OF HONOLULU

ISLAND OF OAHU

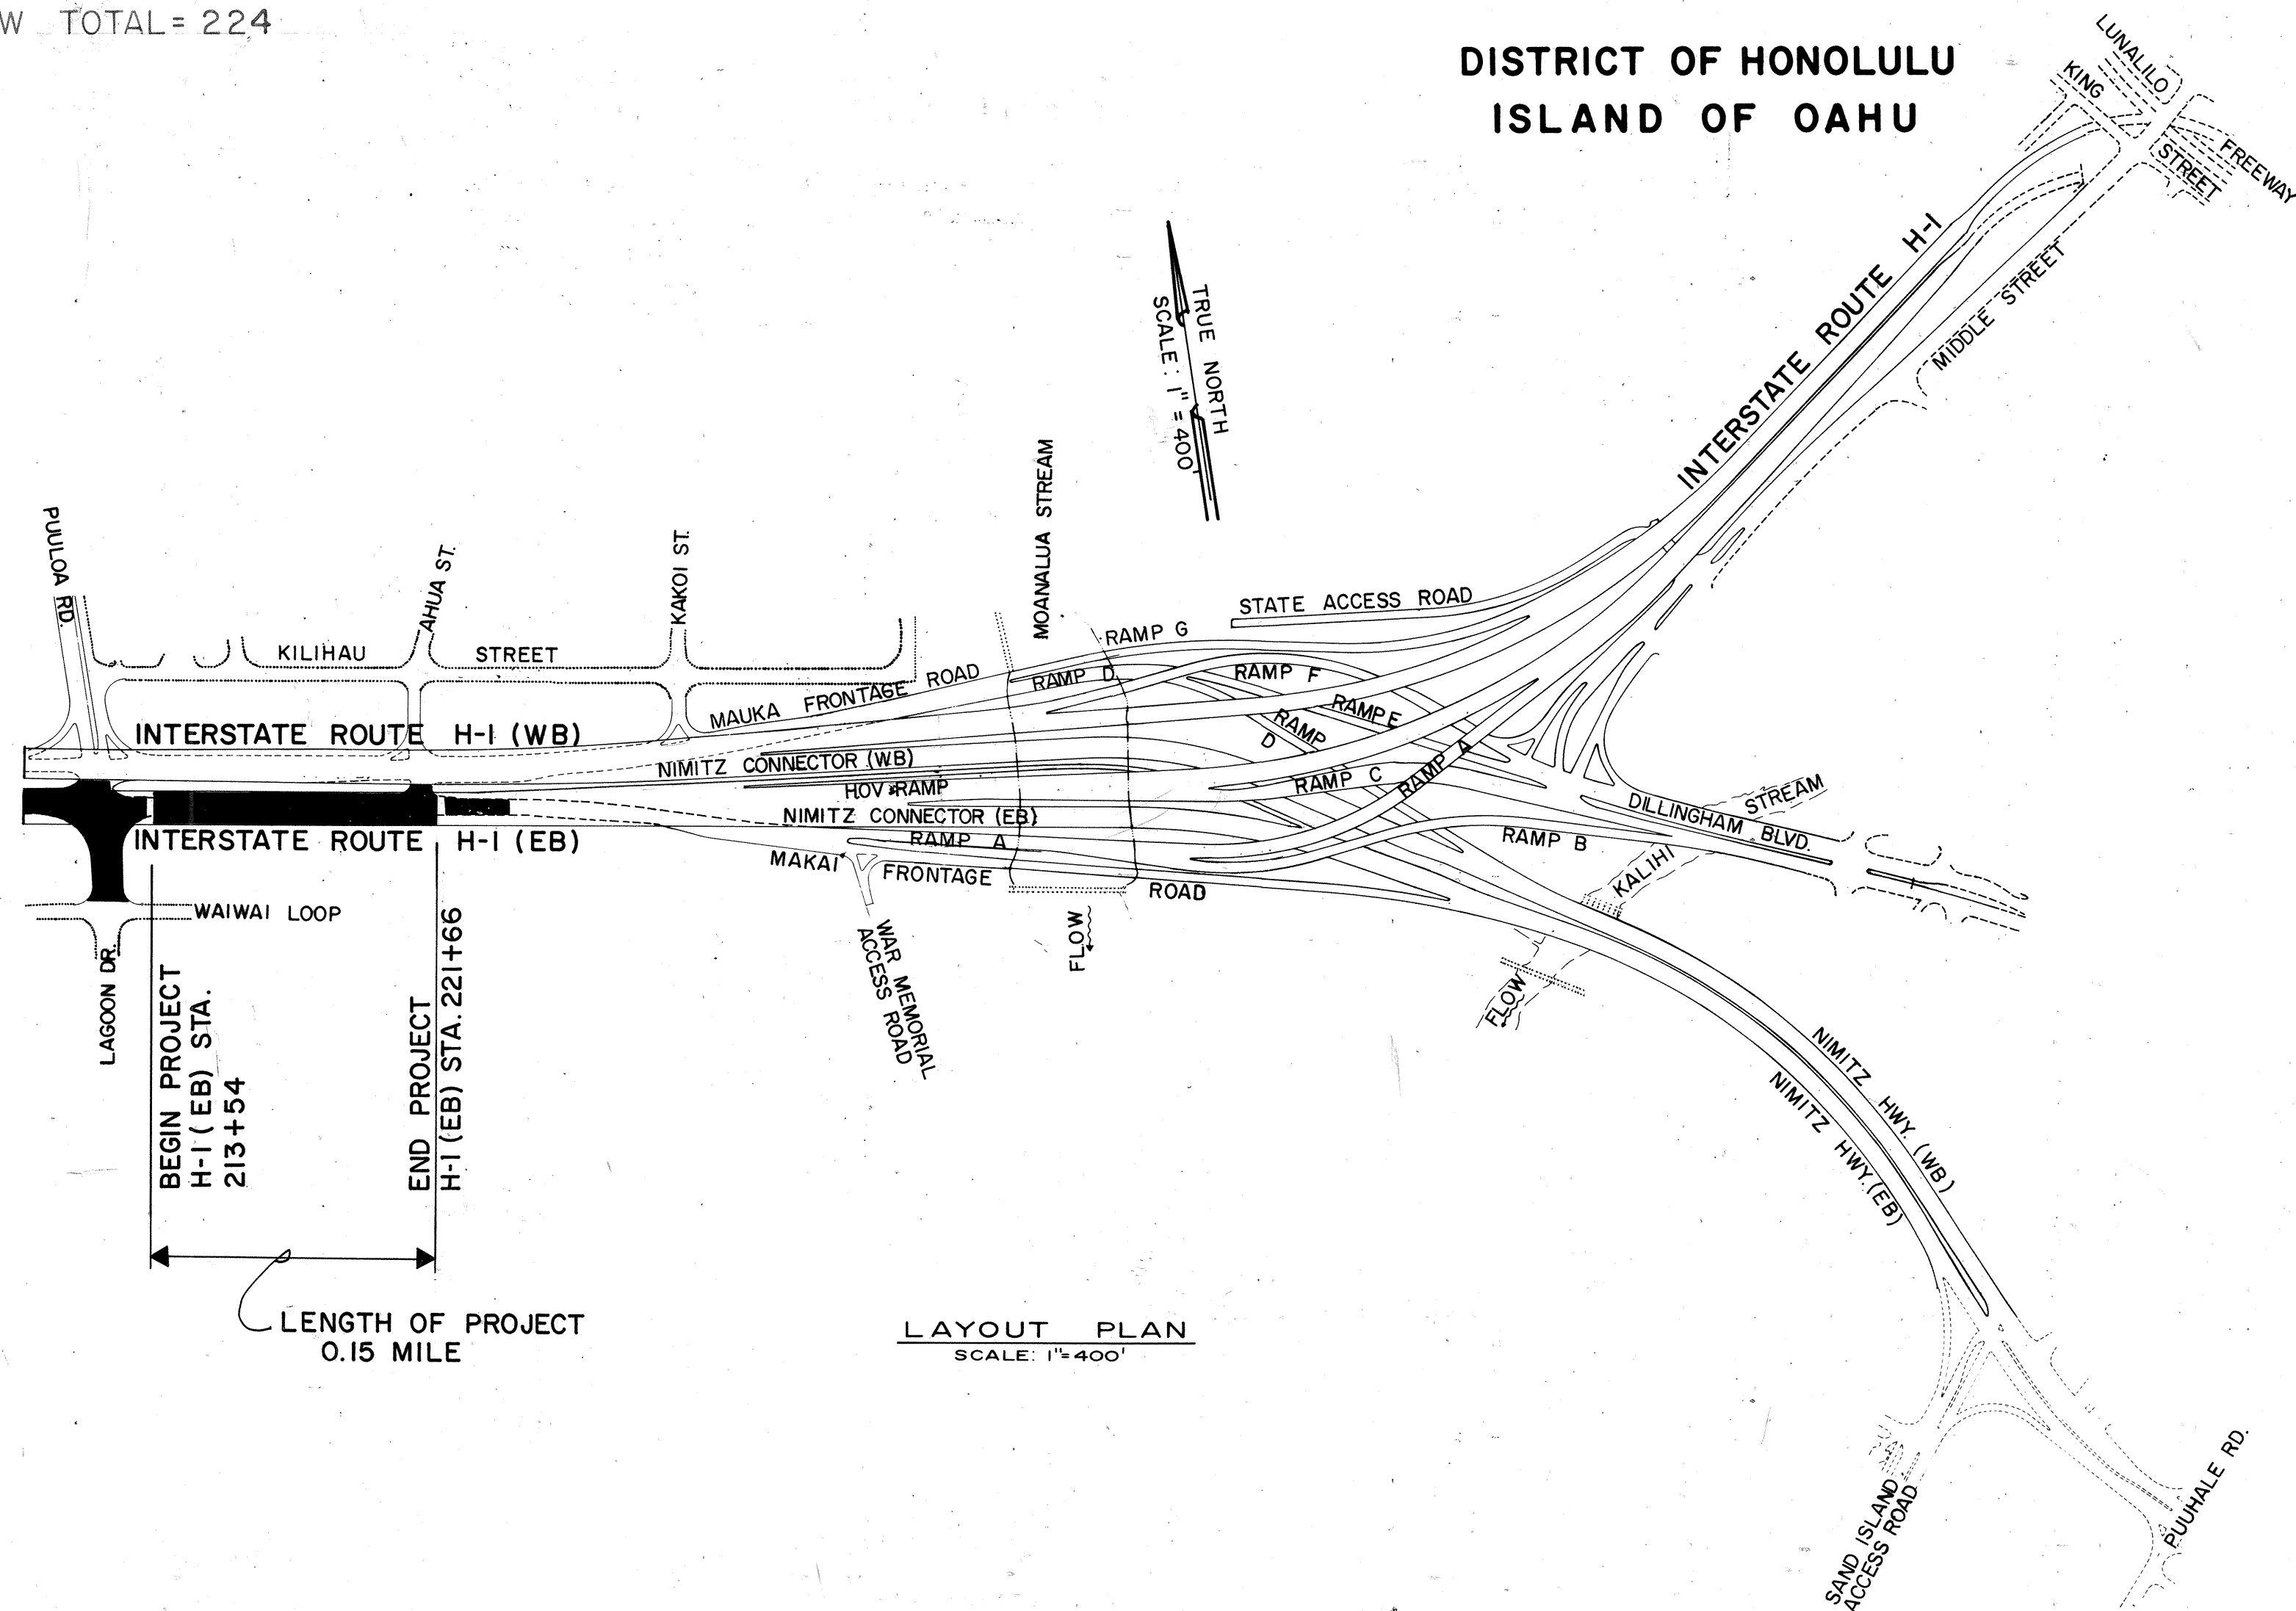

DESIGN CLASSIFICATION

DESIGN ADT (1994).....98,000

DHV.....10,800

D.....60/40

T.....5%

V.....60 MPH

CHANGES MADE DURING CONSTRUCTION HAVE BEEN INCORPORATED ON THESE PLANS EXCEPT CHANGES IN THE ORIGINAL THEORETICAL QUANTITIES. FOR ACTUAL QUANTITIES, REFER TO PROJECT LEDGER AND/OR COMPUTATION BOOK.

[Signature]

RESIDENT ENGINEER

11/22/88

DATE

DEPARTMENT OF TRANSPORTATION

FEDERAL HIGHWAY ADMINISTRATION

APPROVED:

[Signature]

9/9/83

DIVISION ADMINISTRATOR

DATE

DEPARTMENT OF TRANSPORTATION

STATE OF HAWAII

APPROVED:

[Signature]

Sept 9, 83

DIR. OF TRANSPORTATION

DATE