
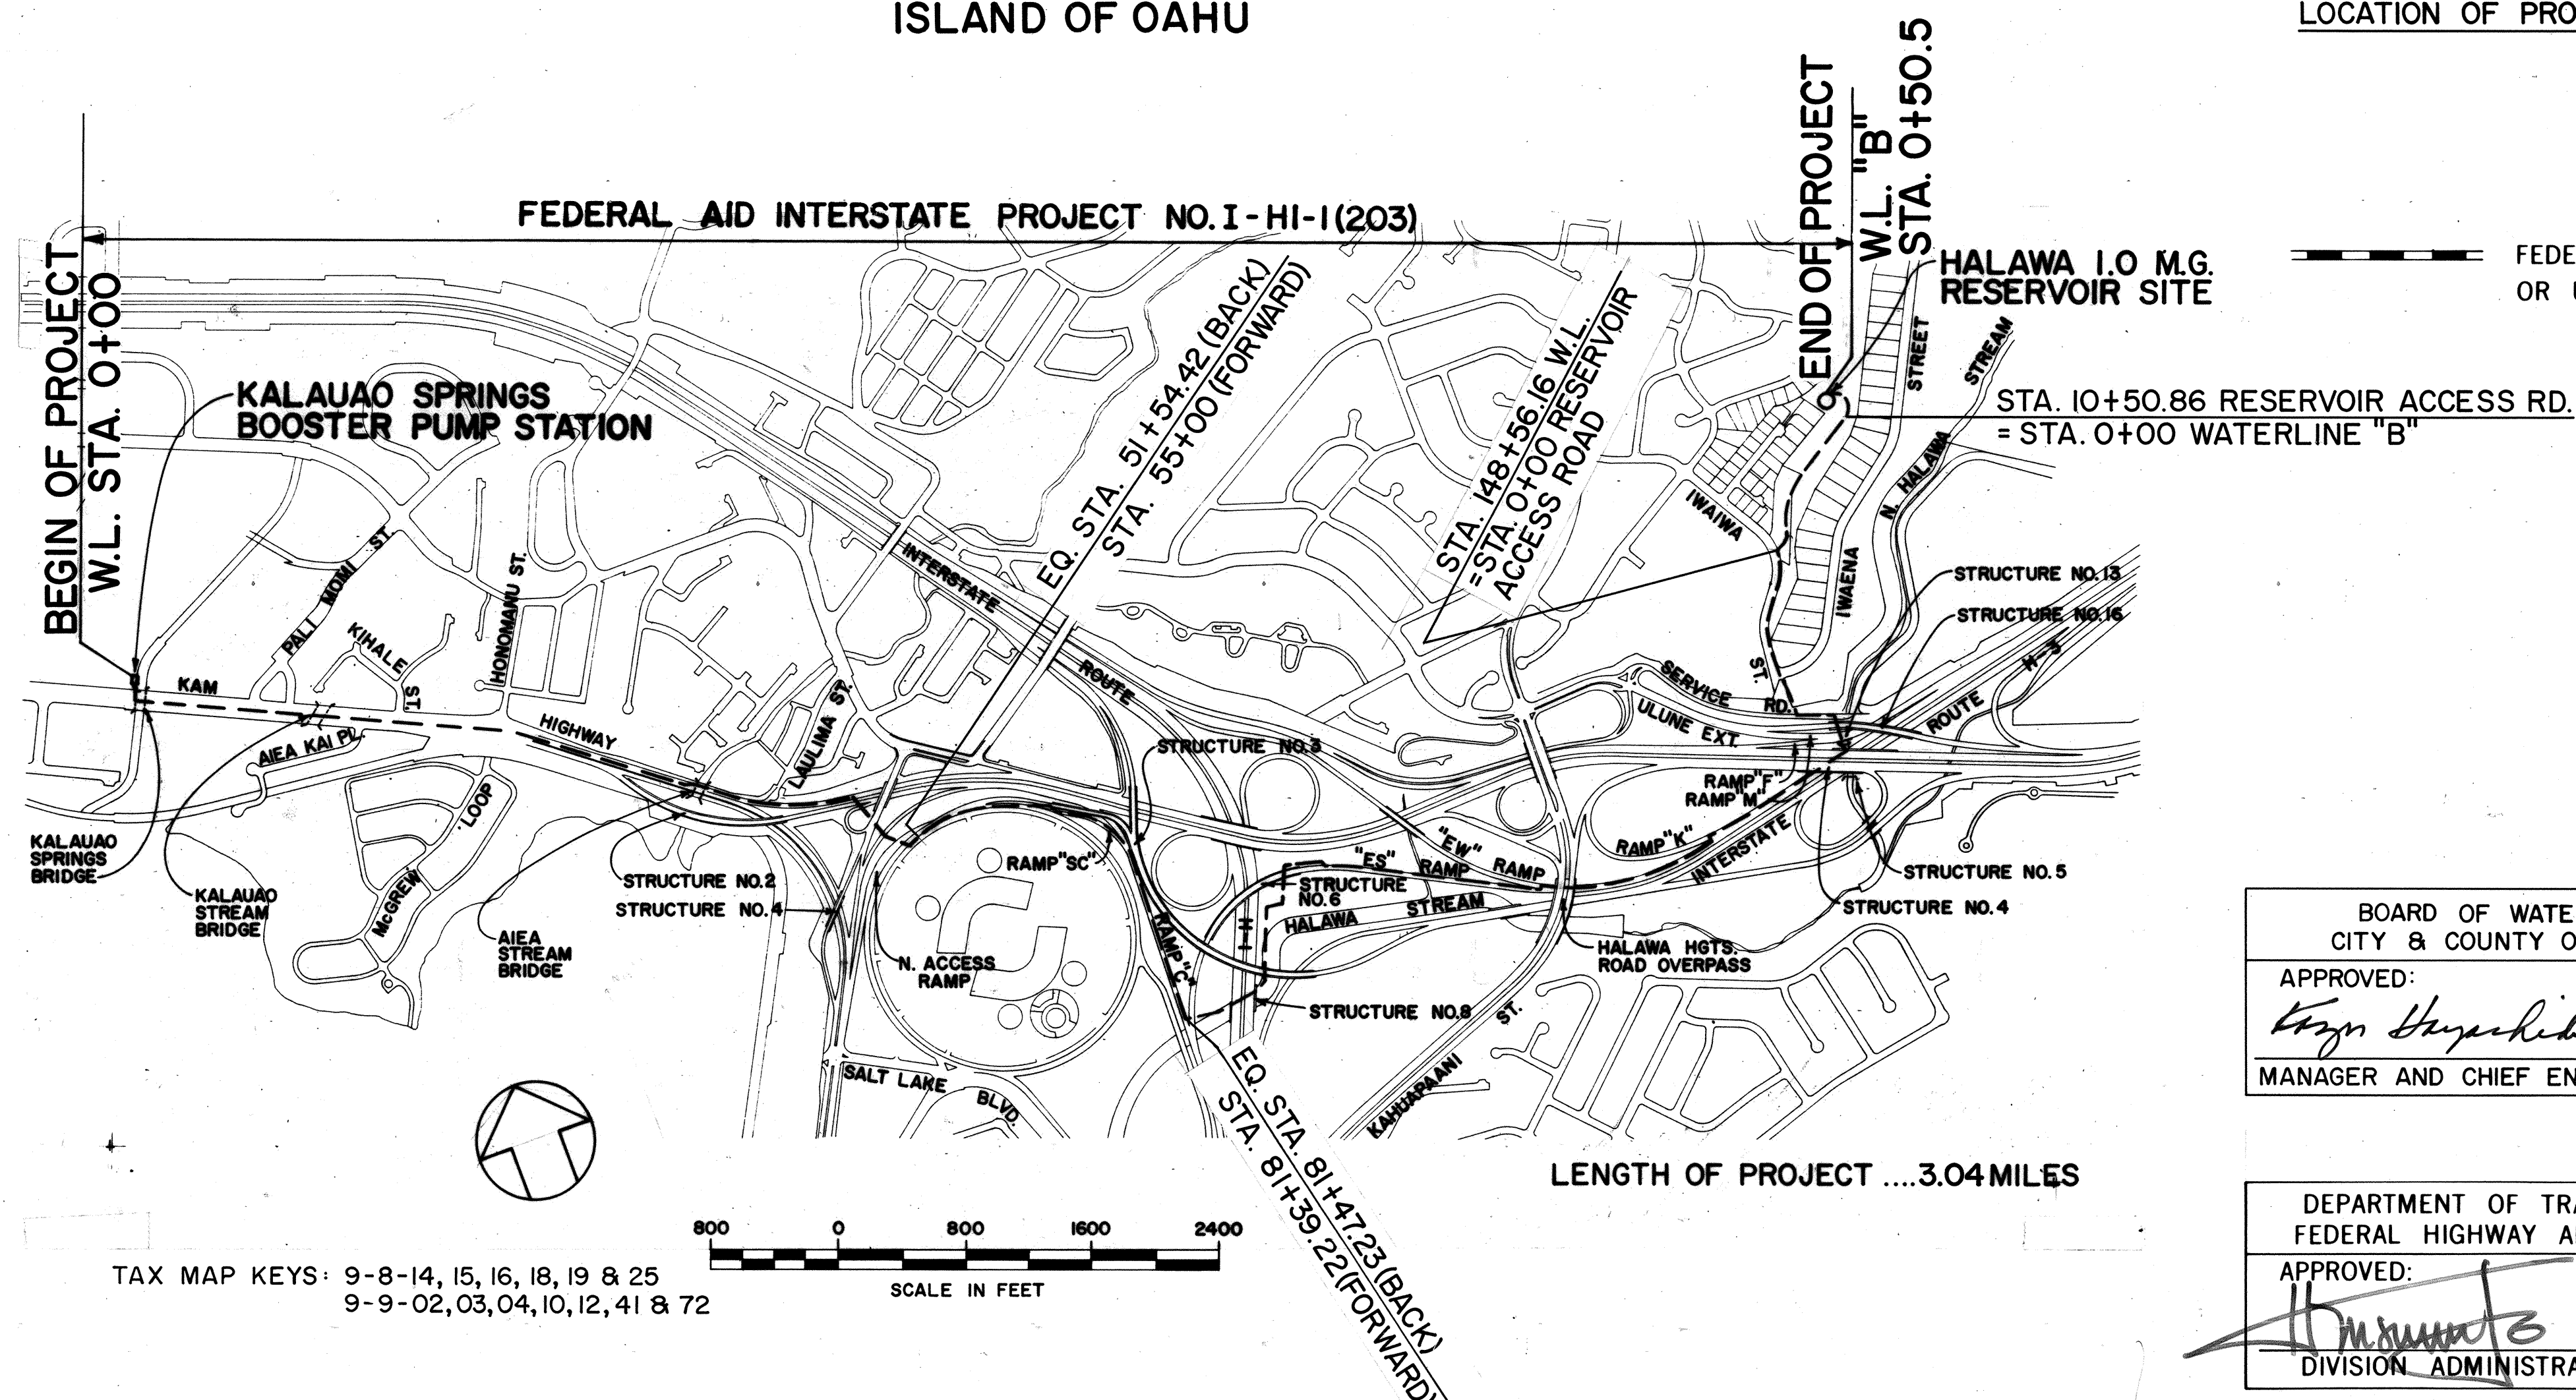


INDEX TO DRAWINGS	
SHEET NO.	DESCRIPTION
1	TITLE SHEET
2	STANDARD PLAN SUMMARY SHEET
3	KEY MAP
4 - 6	CONSTRUCTION NOTES
7 - 11	BORING LOCATIONS AND LOGS
12 - 13	TYPICAL SECTIONS
14 - 28	WATERLINE PLAN AND PROFILE
29 - 30	WATER DETAILS
31	IRRIGATION CONNECTION DETAILS
32 - 34	RESERVOIR ACCESS ROAD PLANS
35	EROSION CONTROL PLAN
36 - 37	RESERVOIR ACCESS RD.-GRADING PLAN
38	RESERVOIR SITE PLAN
39 - 41	RESERVOIR SITE DETAILS
42 - 43	DRAINAGE & MISC. PROFILES
44 - 46	DRAINAGE DETAILS
47	INSTRUMENT HOUSE DETAILS
48 - 49	LANDSCAPING & IRRIGATION SYSTEM
50 - 53	CROSS - SECTIONS
54 - 66	TRAFFIC CONTROL PLANS
67 - 72	STREAM CROSSINGS
73 - 80	RESERVOIR STRUCTURAL DETAILS
81 - 87	ELECTRICAL PLANS

① 49S-1, IS SUPPLEMENT SHEET TO THE CONTRACT PLANS. TOTAL = 88

STATE OF HAWAII  
DEPARTMENT OF TRANSPORTATION  
HIGHWAYS DIVISION  
HONOLULU, HAWAII  
"AS BUILT"  
PLANS FOR  
CONSTRUCTION OF A PORTION OF  
INTERSTATE ROUTE H-1  
HALAWA INTERCHANGE TO MIDDLE STREET INTERCHANGE  
NON-POTABLE WATER SYSTEM  
(KALAUAO SPRINGS TO HALAWA RESERVOIR)  
FEDERAL AID INTERSTATE PROJECT NO. IR-HI-1(203)  
DISTRICT OF EWA  
ISLAND OF OAHU

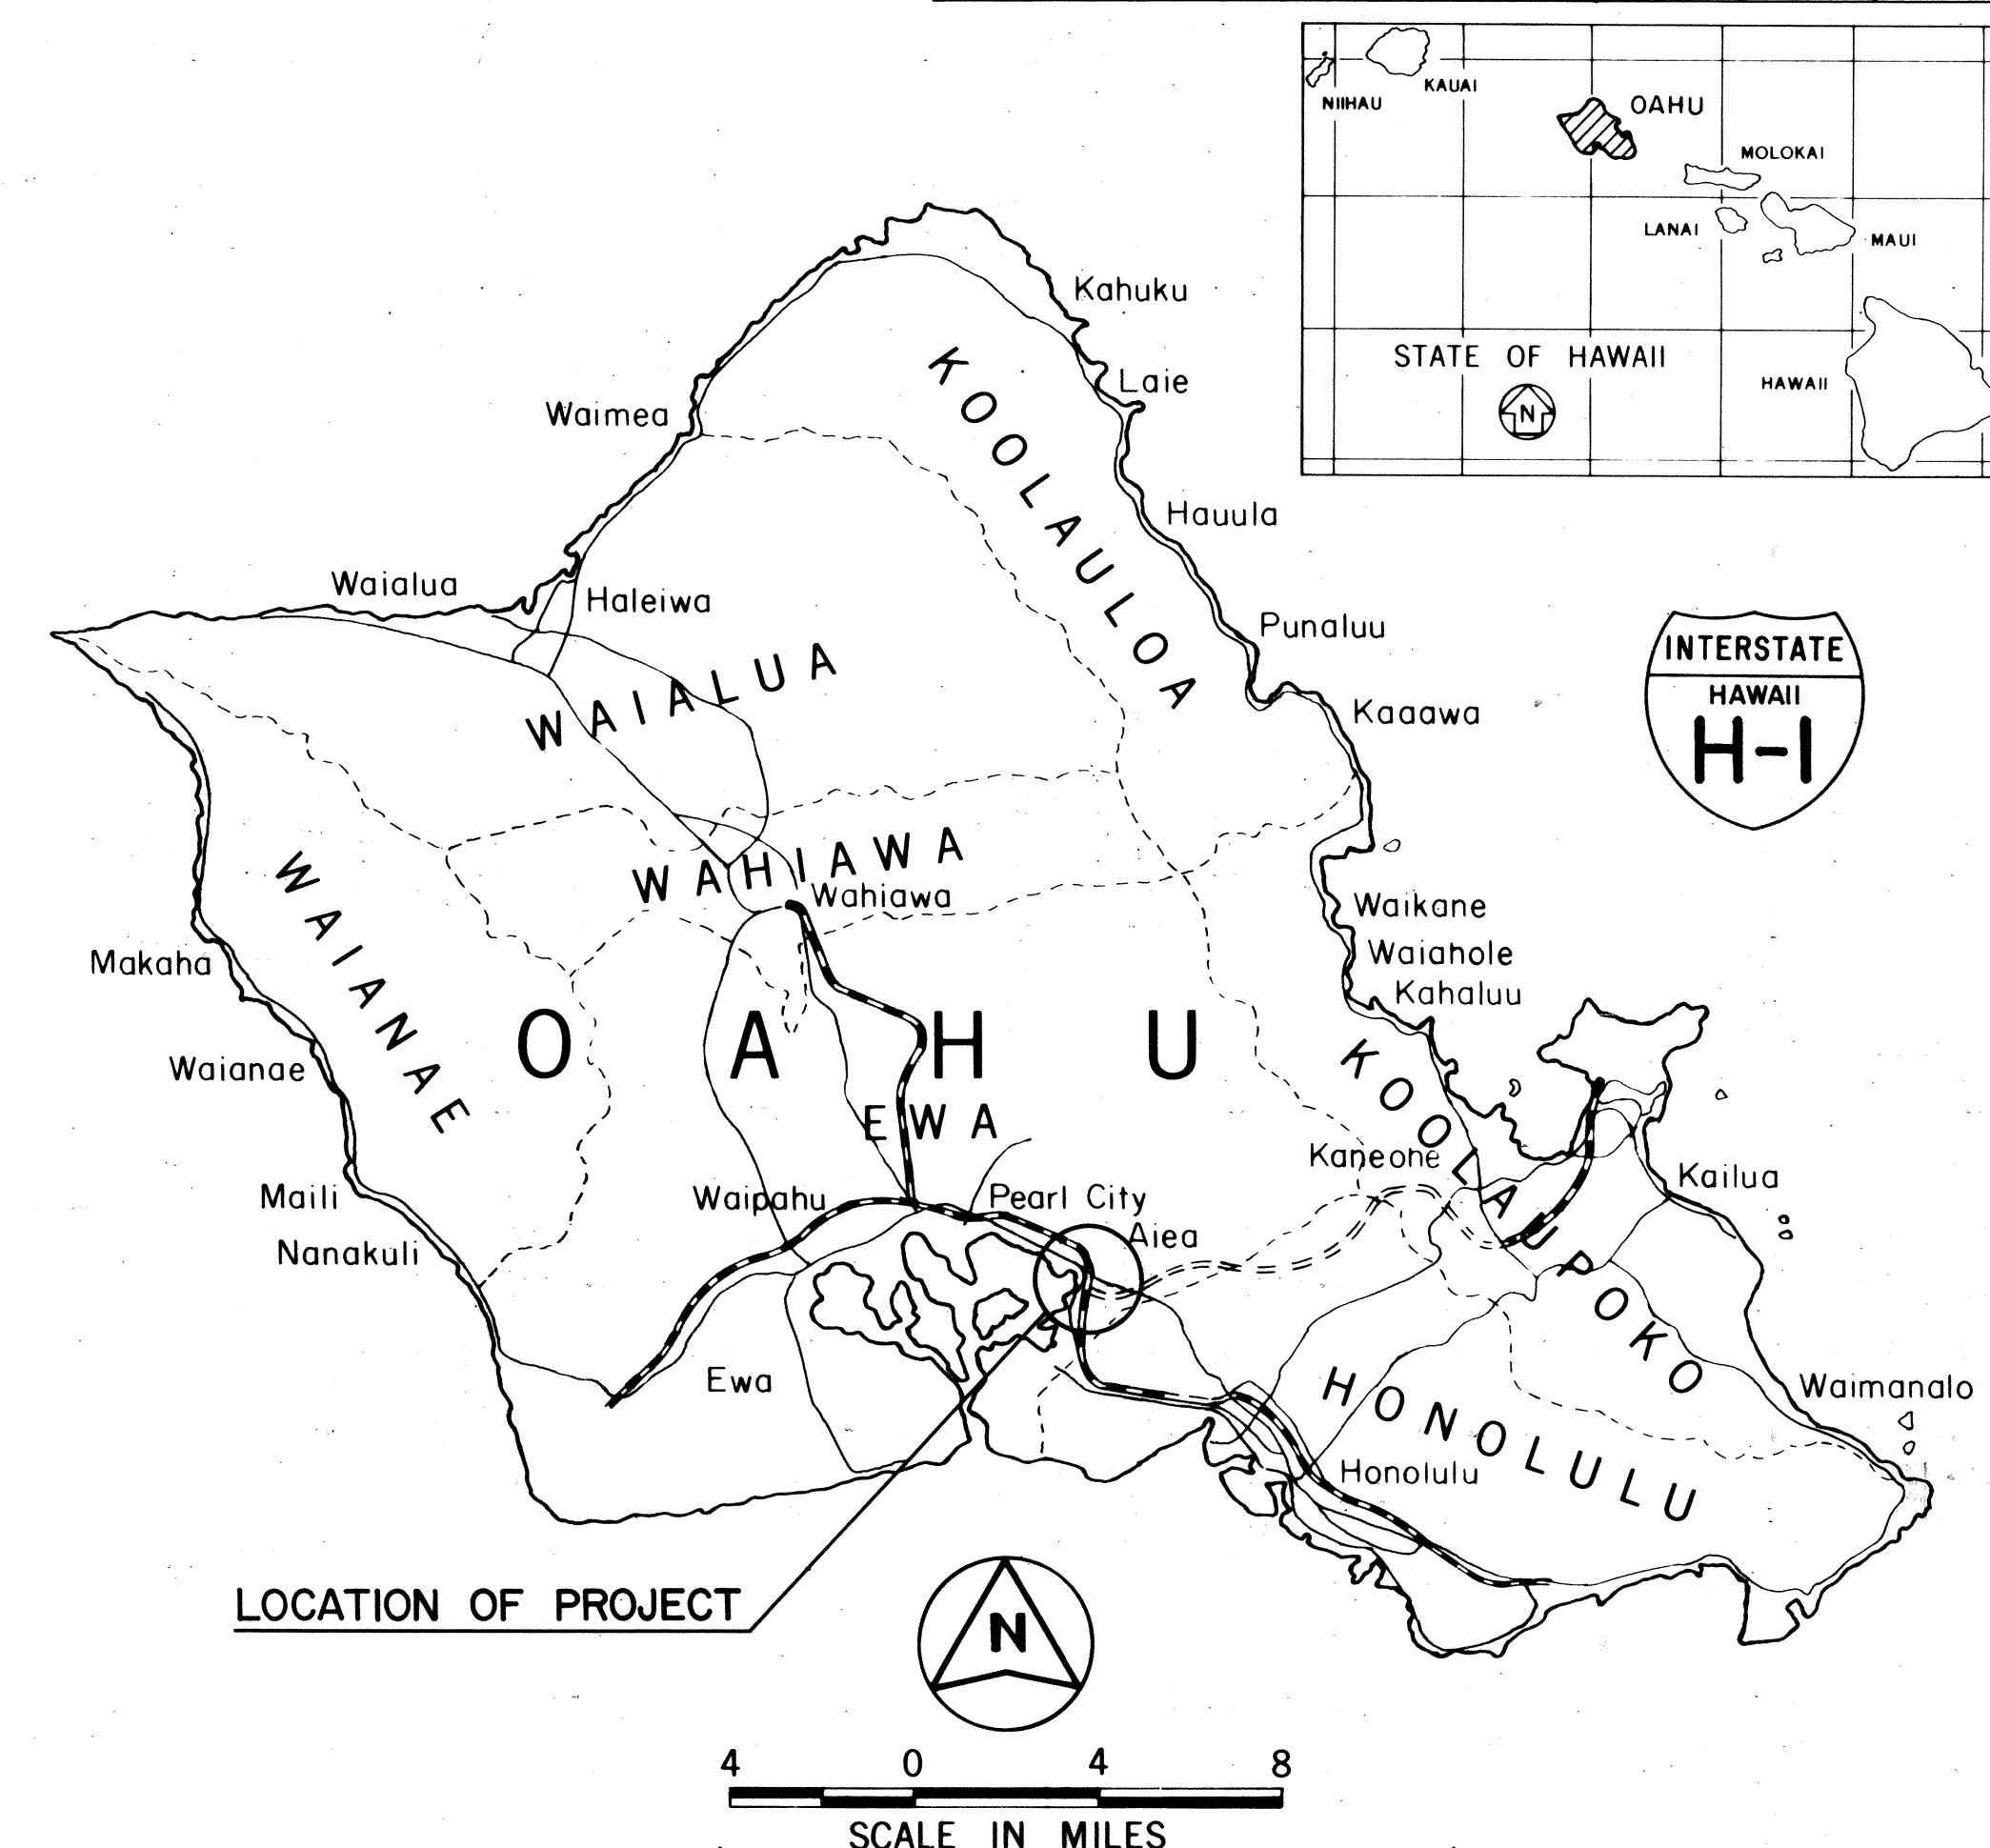

CHANGES MADE DURING CONSTRUCTION HAVE BEEN INCORPORATED ON THESE PLANS EXCEPT CHANGES IN THE ORIGINAL THEORETICAL QUANTITIES. FOR ACTUAL QUANTITIES, REFER TO PROJECT LEDGER AND/OR COMPUTATION BOOK.

*M. J. Brown* 3-5-90  
RESIDENT ENGINEER DATE

BOARD OF WATER SUPPLY  
CITY & COUNTY OF HONOLULU  
APPROVED: *Herbert Tao* 9/4/86  
MANAGER AND CHIEF ENGINEER DATE

DEPARTMENT OF TRANSPORTATION  
FEDERAL HIGHWAY ADMINISTRATION  
APPROVED: *Herbert Tao* 9-24-86  
DIVISION ADMINISTRATOR DATE

DEPARTMENT OF TRANSPORTATION  
STATE OF HAWAII  
APPROVED: *Charles R. Brown* 8/26/86  
DIR. OF TRANSPORTATION DATE

AKINAKA & ASSOC., LTD. DESIGNED BY  
HERBERT TAO P. S. & E. BY  
548-6932 SEP. 1986  
PHONE DATE