


INDEX TO DRAWINGS	
SHEET NO.	DESCRIPTION
1	TITLE SHEET
2	STANDARD PLANS SUMMARY
3-4	NOTES
5-7	TYPICAL SECTIONS
8-18	PLAN AND PROFILES
19-20	DETAILED ROADWAY PLAN
21-23	RETAINING WALL PROFILES
24-29S-2	RETAINING WALL DETAILS
30-31	SUPERELEVATION DIAGRAMS
32-37	GRADING AND DRAINAGE PLANS
38-39	DRAINAGE PROFILES
40-45	DRAINAGE DETAILS
46	BORING LOGS
47-50	WATER AND SEWER SYSTEMS
51-53	PAVEMENT MARKINGS AND SIGNS
54-55	TRAFFIC CONTROL PLAN
56-76	ELECTRICAL PLANS
77-109	CROSS SECTIONS

- 29S-1 & 29S-2 RETAINING WALL DETAILS
 - 42S-1 DRAINAGE DETAILS
 - 49S-1 WATER DETAILS
 - 61S-1 ELECTRICAL & TELEPHONE DUCTLINE PLAN I
- TOTAL SHEET COUNT AFTER "AS-BUILT" POSTINGS: 114 SHEETS


STATE OF HAWAII
DEPARTMENT OF TRANSPORTATION
HIGHWAYS DIVISION
HONOLULU, HAWAII

PLANS FOR
CONSTRUCTION OF A PORTION OF
INTERSTATE ROUTE H-1
PAIWA STREET INTERCHANGE
PROJECT NO. HIC-01-90

DISTRICT OF EWA
ISLAND OF OAHU

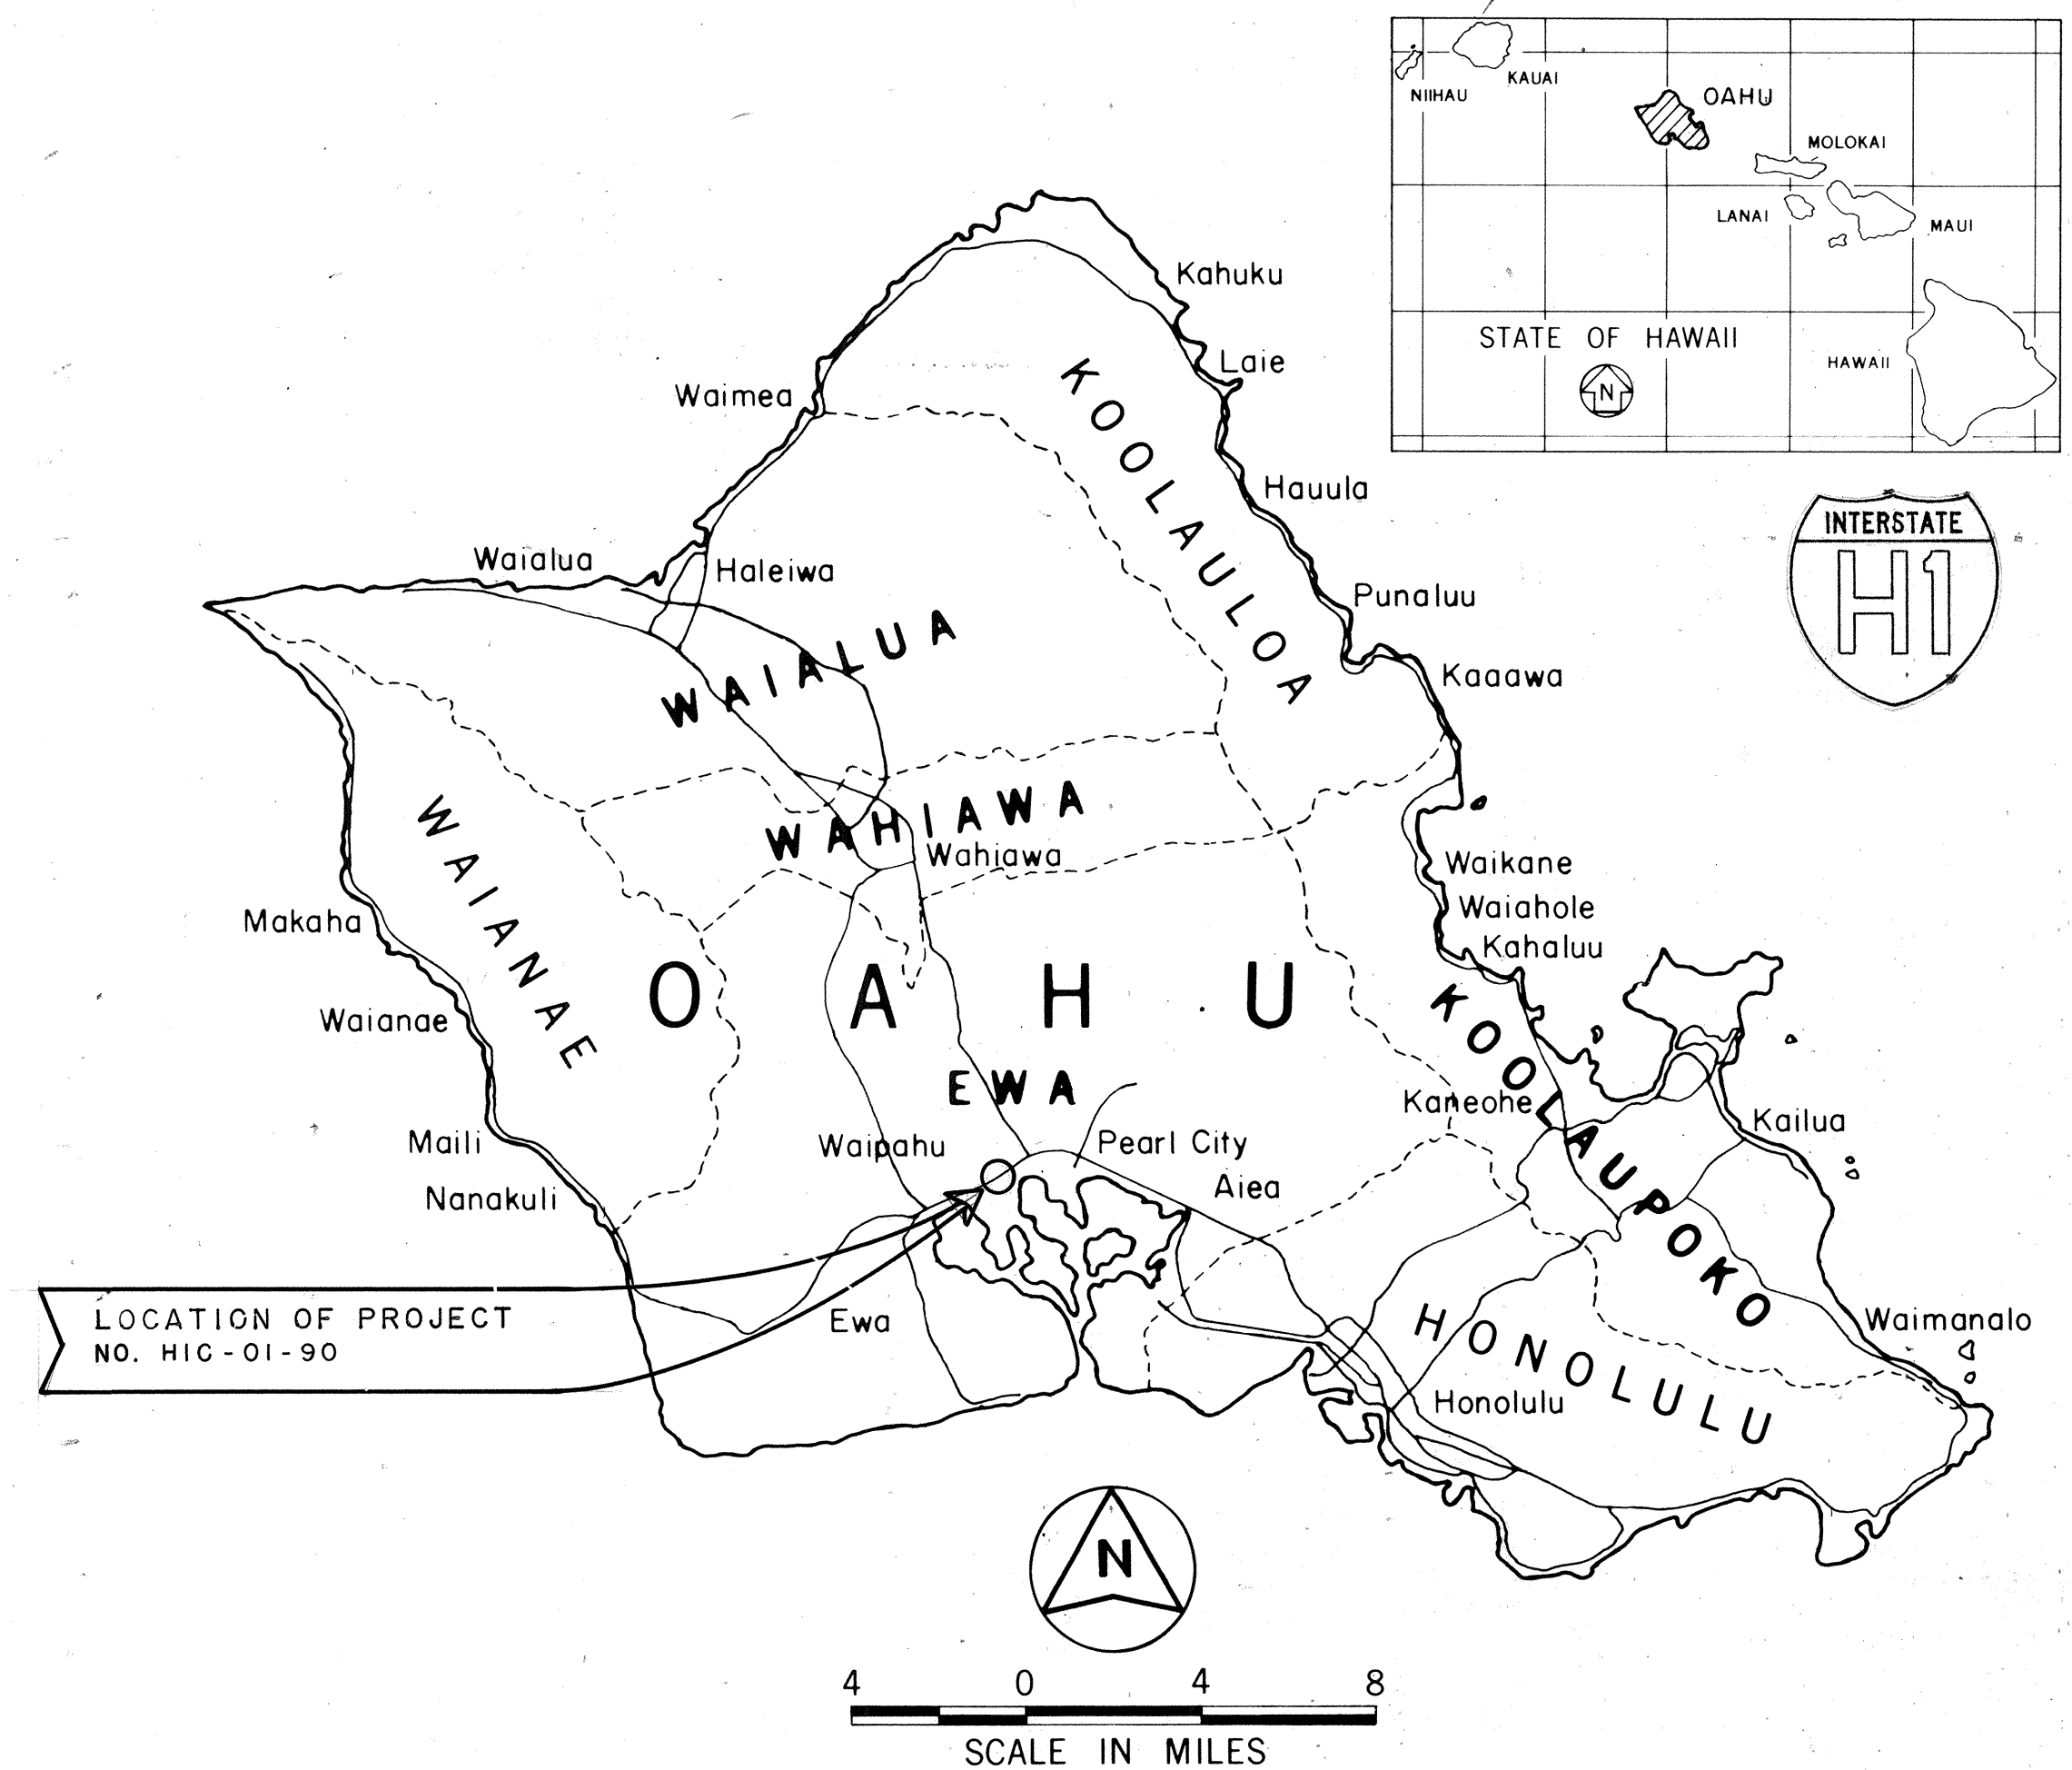

FED. ROAD DIST. NO.	STATE	PROJ. NO.	FISCAL YEAR	SHEET NO.	TOTAL SHEETS
HAWAII	HAW.	HIC-01-90	1991	I	109

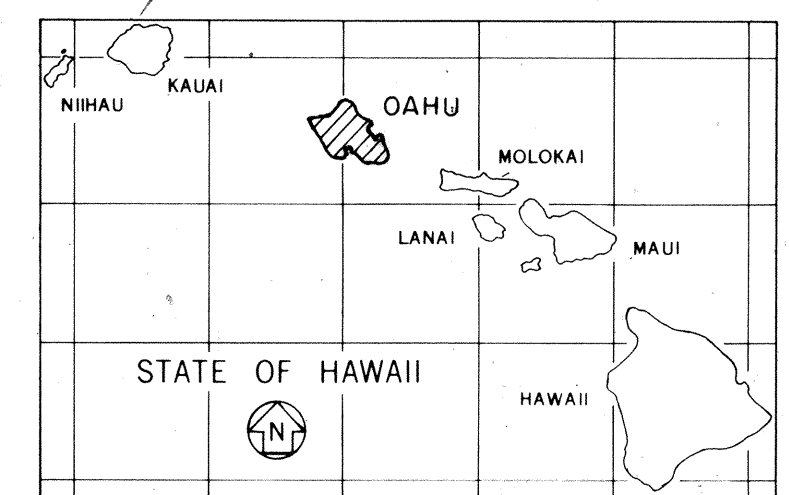


MILE POST 6.770 TO MILE POST 7.760

DESIGN DESIGNATION

CONTROL OF ACCESS	- FULL
CURRENT ADT (1984)	51,600
DESIGN ADT (1995)	80,000
DHV	8,800
D	65/35
T	3 %
V	70 M.P.H.

DEPARTMENT OF TRANSPORTATION
STATE OF HAWAII

APPROVED: *Charles J. Pratt* 5/22/91
DIR. OF TRANSPORTATION DATE

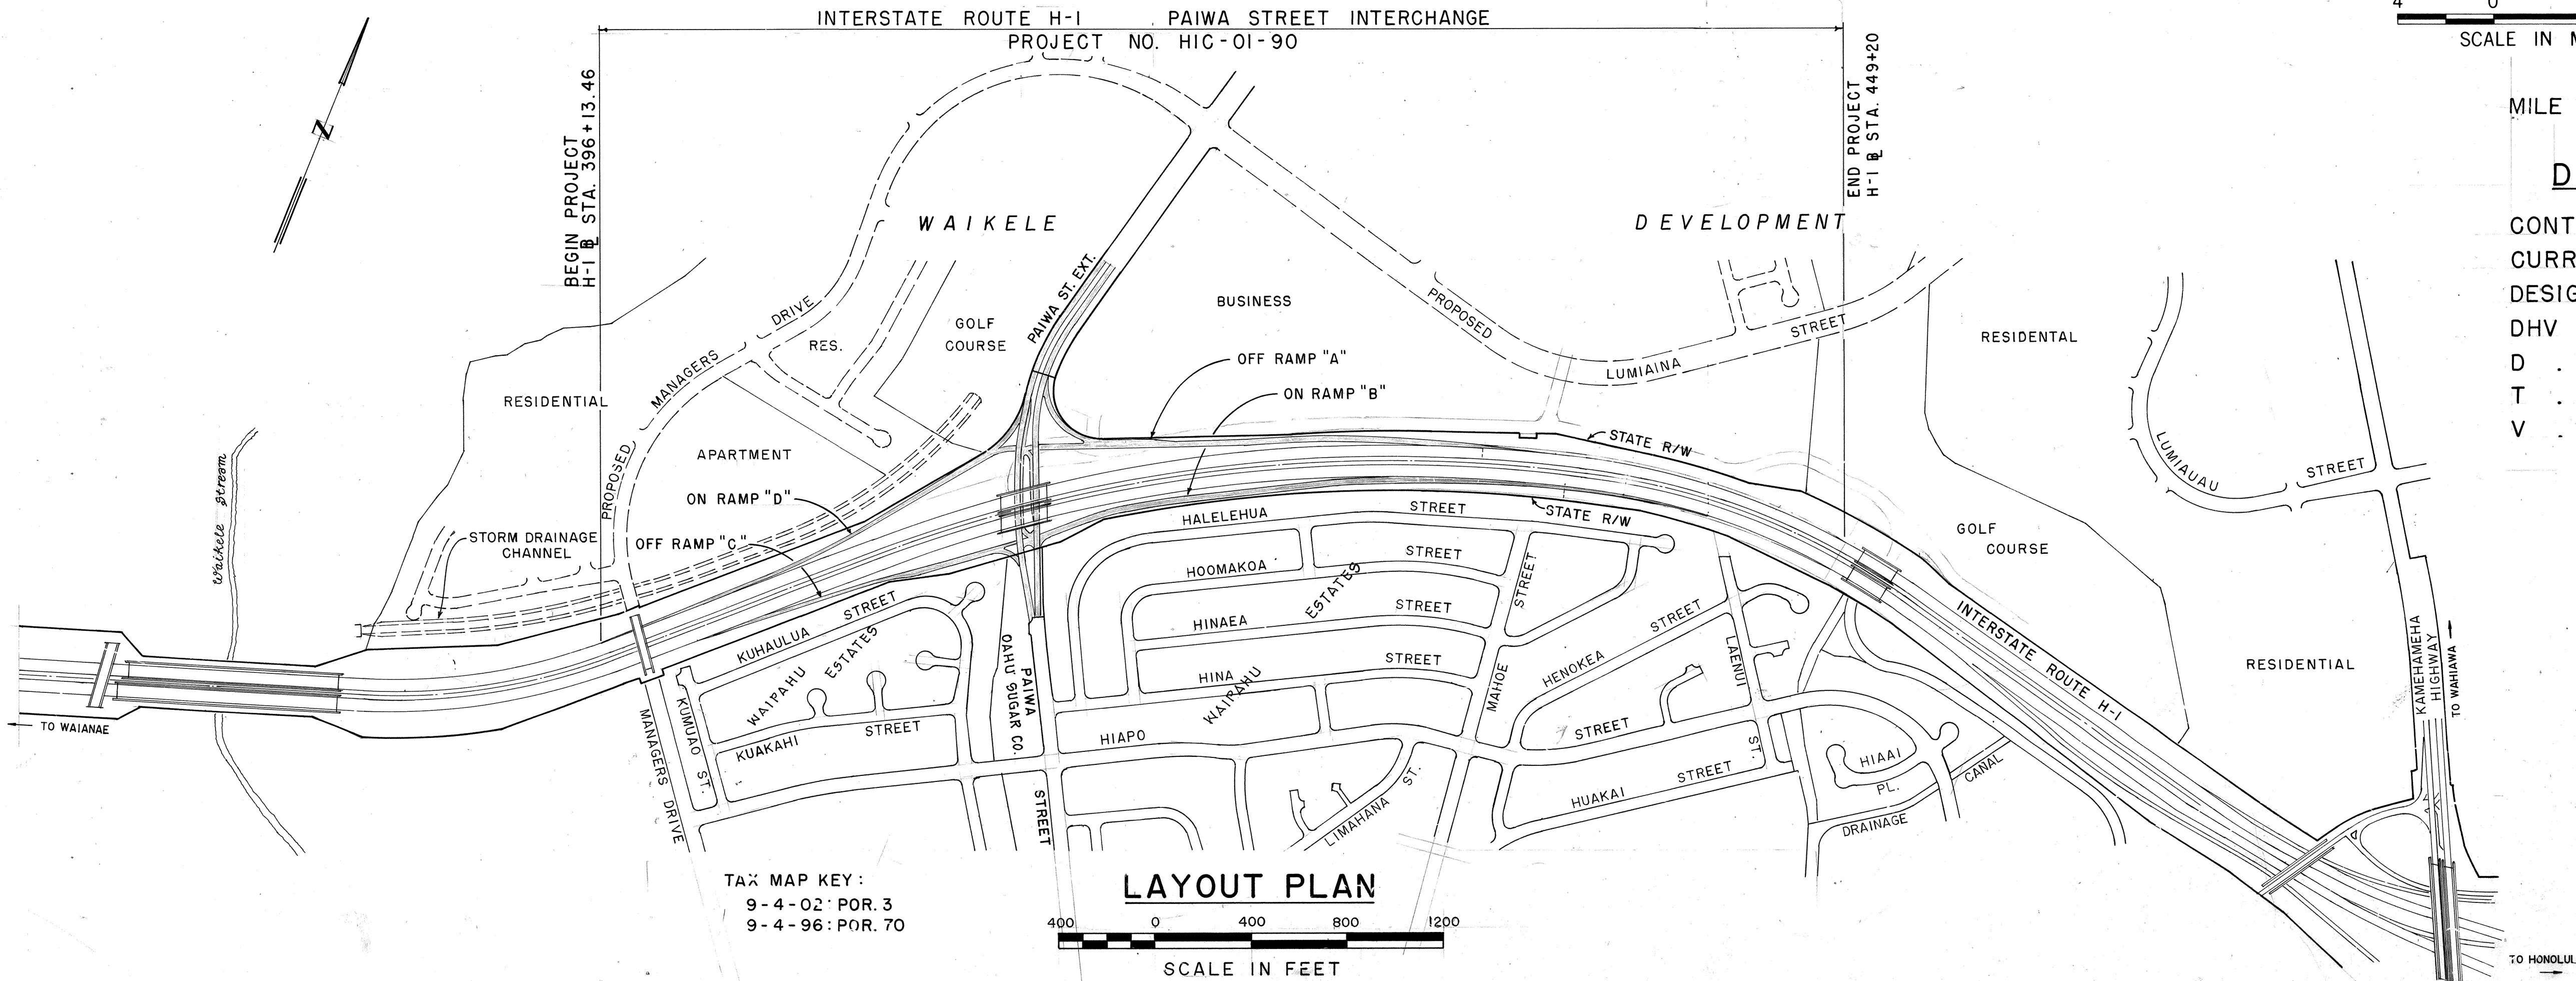

COMMUNITY PLANNING, INC. DESIGNED BY
HWY - CM P. S. & E. BY
587-2187 PHONE
AUG. 1991 DATE