


INDEX TO DRAWINGS	
SHEET NO.	DESCRIPTION
1	TITLE SHEET
2	STANDARD PLANS SUMMARY
3	GENERAL NOTES AND LEGEND
① 4 – 24	TYPICAL SECTIONS
25 – 29	GENERAL LAYOUT PLANS
30 – 80	ROADWAY PLANS
81 – 84	MOVABLE BARRIER LAYOUT DIAGRAMS
85 – 96	CROSS OVER LANE PLANS
97 – 98	PLAN, BTV STORAGE SITE
99 – 101	CROSS OVER LANE PROFILES
102	WALL PROFILES – BTV SITE
103	PAVEMENT MARKING LEGEND, DETAILS AND NOTES
② 104– 154	PAVEMENT MARKING & STRIPING PLANS
155 – 162	SIGNING PLAN
163	SIGN NOTES AND SUMMARY
164 – 166	PANEL LAYOUT DETAILS
167 – 172	SIGN ELEVATIONS
173 – 176	SPRINKLER NOTES AND PLANS
177	QUADGUARD ATTENUATOR
178	TYPICAL MOVABLE STEEL GATE PLAN
179	RIGID BARRIER GUARDRAIL MODIFIED TYPE 4
180	SWING GATE DETAILS
181 – 184	MISCELLANEOUS DETAILS
③ 185 – 186	DRAINAGE DETAILS
④ 187	DRAINAGE PROFILES AND SUMMARY
⑤ 188 – 293	ELECTRICAL PLANS
294 – 313	STRUCTURAL PLANS
⑥ 314 – 323	BARRIER TRANSFER VEHICLE (BTV) STORAGE FACILITY PLANS
324 – 338	CROSS SECTIONS – CROSS OVER LANES
⑦ 339 – 344	BORING LOGS

313	ELECTRICAL PLANS
23	STRUCTURAL PLANS
23	BARRIER TRANSFER VEHICLE (BTV)
38	STORAGE FACILITY PLANS
44	CROSS SECTIONS - CROSS OVER LANES
44	BORING LOGS

DISTRICTS OF EWA AND HONOLULU


ISLAND OF OAHU

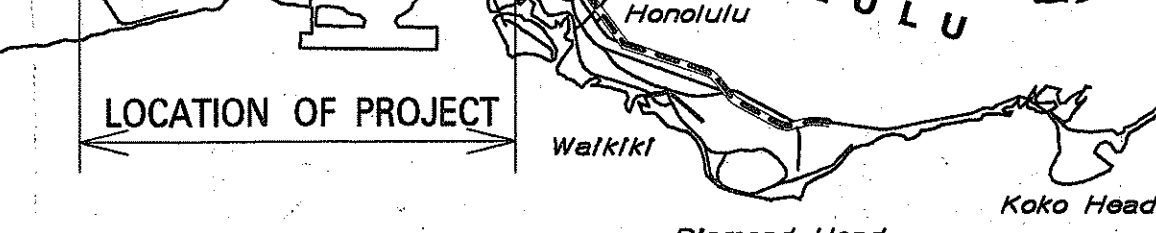

LOCATION OF PROJECT

SCALE IN MILES

MILE POST 6.34 TO MILE POST 19.34

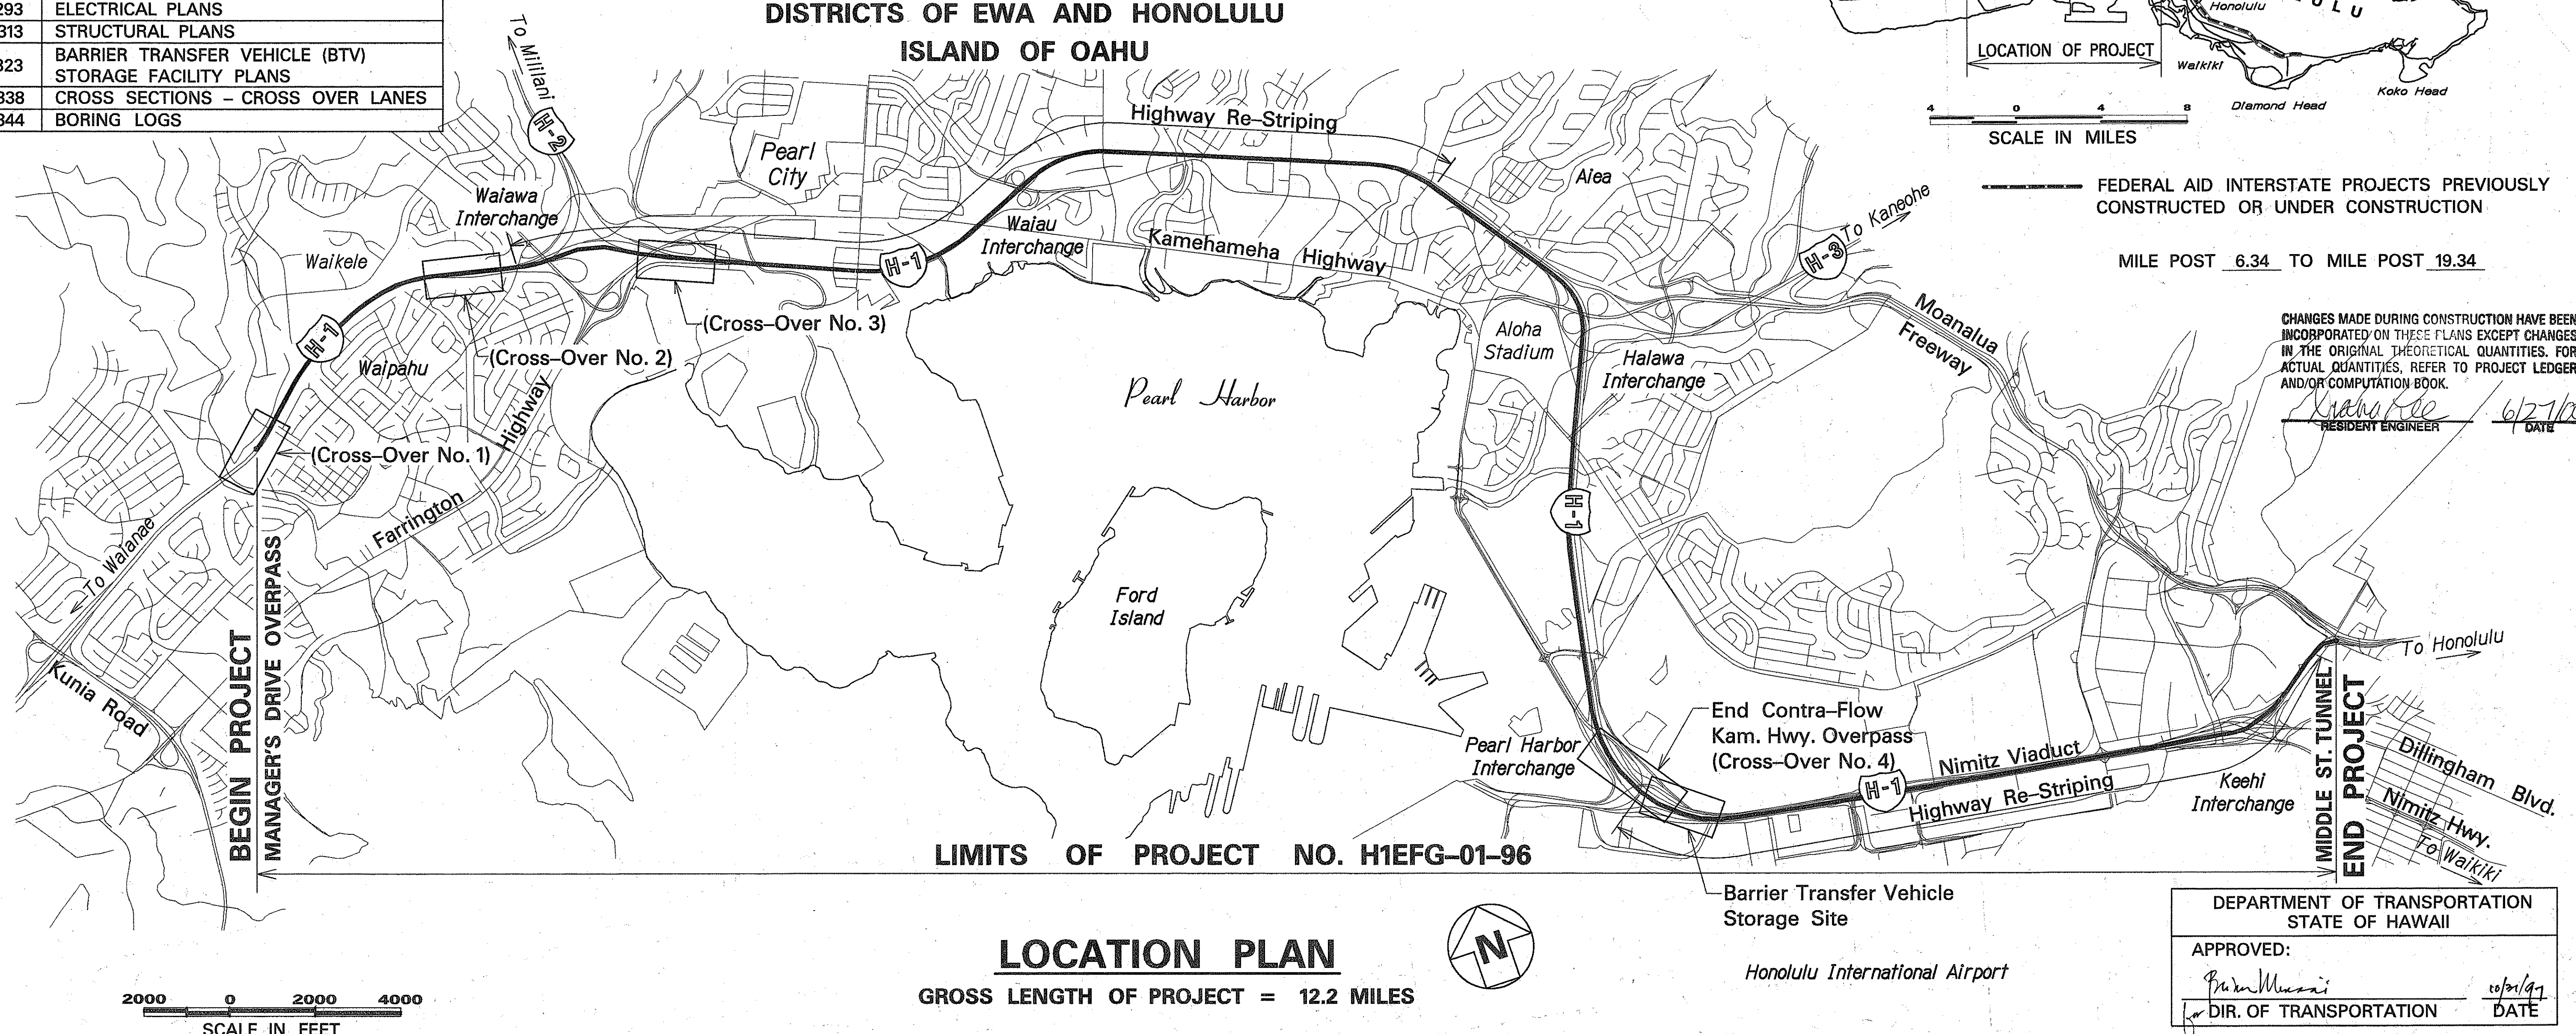

LOCATION PLAN

GROSS LENGTH OF PROJECT = 12.2 MILES

LIMITS OF PROJECT NO. H1EFG-01-96

HONOLULU INTERNATIONAL AIRPORT

CHANGES MADE DURING CONSTRUCTION HAVE BEEN INCORPORATED ON THESE PLANS EXCEPT CHANGES IN THE ORIGINAL THEORETICAL QUANTITIES. FOR ACTUAL QUANTITIES, REFER TO PROJECT LEDGER AND/OR COMPUTATION BOOK.

RESIDENT ENGINEER DATE

DEPARTMENT OF TRANSPORTATION STATE OF HAWAII	
APPROVED:	
 DIR. OF TRANSPORTATION	02/21/97 DATE




FEDERAL AID INTERSTATE PROJECTS PREVIOUSLY
CONSTRUCTED OR UNDER CONSTRUCTION

MILE POST 6.34 TO MILE POST 19.34

CHANGES MADE DURING CONSTRUCTION HAVE BEEN INCORPORATED ON THESE PLANS EXCEPT CHANGES IN THE ORIGINAL THEORETICAL QUANTITIES. FOR ACTUAL QUANTITIES, REFER TO PROJECT LEDGER AND/OR COMPUTATION BOOK.

Kravis Lee 6/27/00
RESIDENT ENGINEER DATE

DEPARTMENT OF TRANSPORTATION STATE OF HAWAII	
APPROVED: 	
DIR. OF TRANSPORTATION	DATE