


WARNING:
PROJECT SITE CONTAINS EXISTING ELECTRICAL LINES (BOTH OVERHEAD & UNDERGROUND), ENERGIZED AT VARIOUS LOW (BELOW 600V) AND MEDIUM VOLTAGES. THE CONTRACTOR SHALL ASSUME THAT THOSE LINES CANNOT BE DE-ENERGIZED AND SHALL INCLUDE IN HIS WORK SUCH EQUIPMENT/ MATERIALS/ PROCEDURES/ METHODS OF CONSTRUCTION TO PROTECT HIS EMPLOYEES, THE PUBLIC, EMPLOYEES OF THE STATE & UTILITIES, AND ANY EXISTING UTILITIES, FACILITIES, ETC.

FED. ROAD DIST. NO.	STATE	FED. AID PROJ. NO.	FISCAL YEAR	SHEET NO.	TOTAL SHEETS
HAWAII	HAW.	1M-HI-1(219)	1998	222	378

ELECTRICAL SYMBOLS

SYMBOL	DESCRIPTION	SYMBOL	DESCRIPTION
—●—	STREET LIGHT STANDARD, SINGLE LUMINAIRE ARM	—e/ug—	EXISTING UNDERGROUND DUCTLINES
—○—	EXISTING STREET LIGHT, ON JOINT POLE	—*e/ug*	EXISTING UNDERGROUND DUCTLINES TO BE REMOVED
—○—	EXISTING STREET LIGHT STANDARD	—e/oh—	EXISTING OVERHEAD ELECTRICAL/SIGNAL LINES
—●—	STREET LIGHT STANDARD, TWIN LUMINAIRE ARM	—*e/oh*	EXISTING OVERHEAD ELECTRICAL/SIGNAL LINES TO BE REMOVED BY RESPECTIVE UTILITY CO.
○P16	EXISTING UTILITY POLE, POLE #16 INDICATED	—E/oh—	OVERHEAD ELECTRICAL/SIGNAL LINES TO BE PROVIDED BY RESPECTIVE UTILITY CO.
●P26	UTILITY POLE, PROVIDED BY RESPECTIVE UTILITY CO.	---L---	STREET LIGHT DUCT & WIRING, SEE DUCT SECTION FOR SIZE & TYPE
⊗P26	EXISTING UTILITY POLE TO BE REMOVED BY RESPECTIVE UTILITY CO.	—t/oh—	EXISTING OVERHEAD SIGNAL LINES
△	POLE MTD XFMR PROVIDED BY HECO	—T/oh—	OVERHEAD SIGNAL LINES TO BE PROVIDED BY HTCO
△	EXISTING POLE MOUNTED XFMR	—sl—	EXISTING STREET LIGHT DUCTLINE & WIRING CONDUIT BELOW GRADE LEVEL, SEE DUCT SECTION FOR SIZE & TYPE
△	EXISTING POLE MOUNTED XFMR TO BE REMOVED BY HECO	—L—	2" STREET LIGHT DUCT & WIRING, CONCEALED IN CONCRETE BARRIER
⊗	PULLBOX PROVIDED BY HECO	—(A)—	DUCT SECTION, DUCT SECTION "A" INDICATED, SEE DETAILS ON SHEETS E29 & E32
---	EXISTING ANCHOR GUYING		
---	ANCHOR GUYING PROVIDED BY RESPECTIVE UTILITY CO.		
—*—*	EXISTING ANCHOR GUYING TO BE REMOVED BY RESPECTIVE UTILITY CO.		
—sl—H—	CUT EXISTING CONDUIT & WIRING, INTERCEPT WITH PULLBOX, SEE STREET LIGHTING PLANS		
---	STUB UP, CONDUIT		

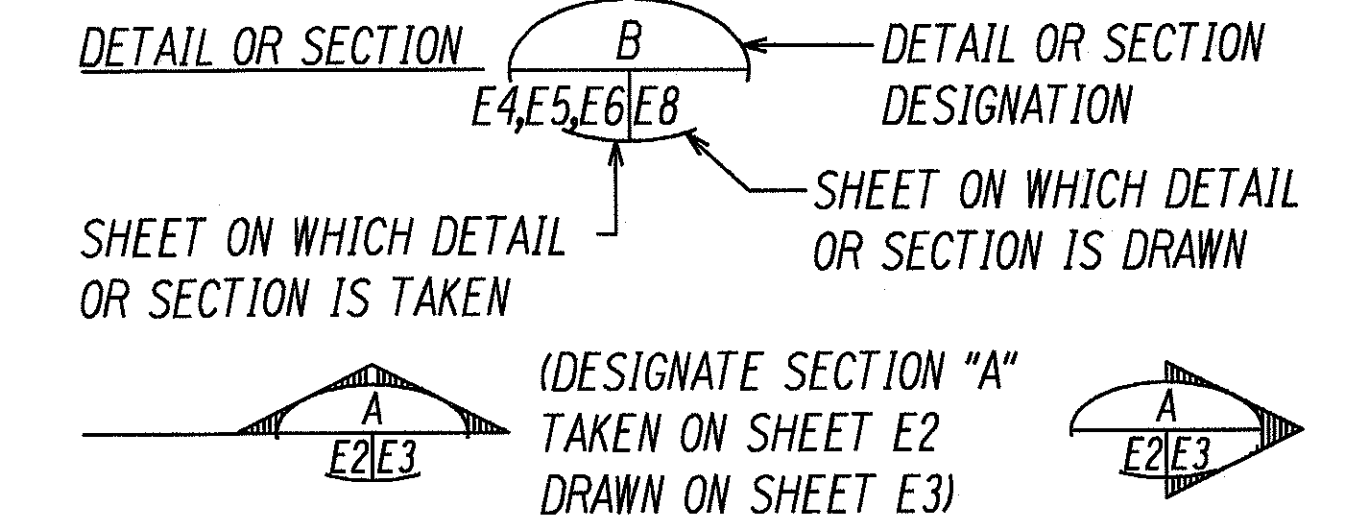


□	EXISTING HANDHOLE/PULLBOX
■	STREET LIGHT PULLBOX, STATE TYPE "B"
▤	STREET LIGHT 2' X 4' PULLBOX, STATE TYPE "D"
▥	STREET LIGHT JUNCTION BOX IN BARRIER, SEE SHEET E29
▧	STREET LIGHT 3' X 5' PULLBOX, 3' X 5' X 4D REINFORCED PLASTIC PULLBOX WITH TWO PIECE "NON-SLIP" POLYMER "PARKWAY" RATED COVERS, SIDE ENTRY KNOCKOUTS, AND GROUND ROD, PROVIDED IN ACCORDANCE WITH HTCO STANDARD DRAWING NO. 34111 EXCEPT WITH "STREET LIGHT" INSCRIBED ON COVER

STREET LIGHT STANDARD IDENTIFICATION LEGEND:

LEGEND	DESCRIPTION
1 121+93	STATION NUMBER
2, CKT #3	STREET LIGHT POLE NUMBER, CIRCUIT NUMBER (VERIFY LIGHT & POLE NO. WITH D.O.T.)
3 14'	POLE CLEAR SETBACK FROM EDGE OF PAVEMENT, SEE NOTE NO. 2 BELOW
4 15'	LUMINAIRE ARM SPAN IN FEET
5 AB	POLE BASE MOUNTING TYPE, SEE NOTE NO. 3 BELOW
6 35'	LUMINAIRE MOUNTING HEIGHT ABOVE PAVEMENT

SYMBOL NOTES:

- "X" THROUGH DASHED ITEM INDICATES EXISTING ITEM TO BE REMOVED.
- "BGR" INDICATES SETBACK IS BEHIND GUARD RAIL; "TB" INDICATES MOUNTING IS ON ON TOP OF BARRIER.
- "AB" INDICATES ANCHOR BASE MOUNTING; "SB" INDICATES SLIP BASE MOUNTING.


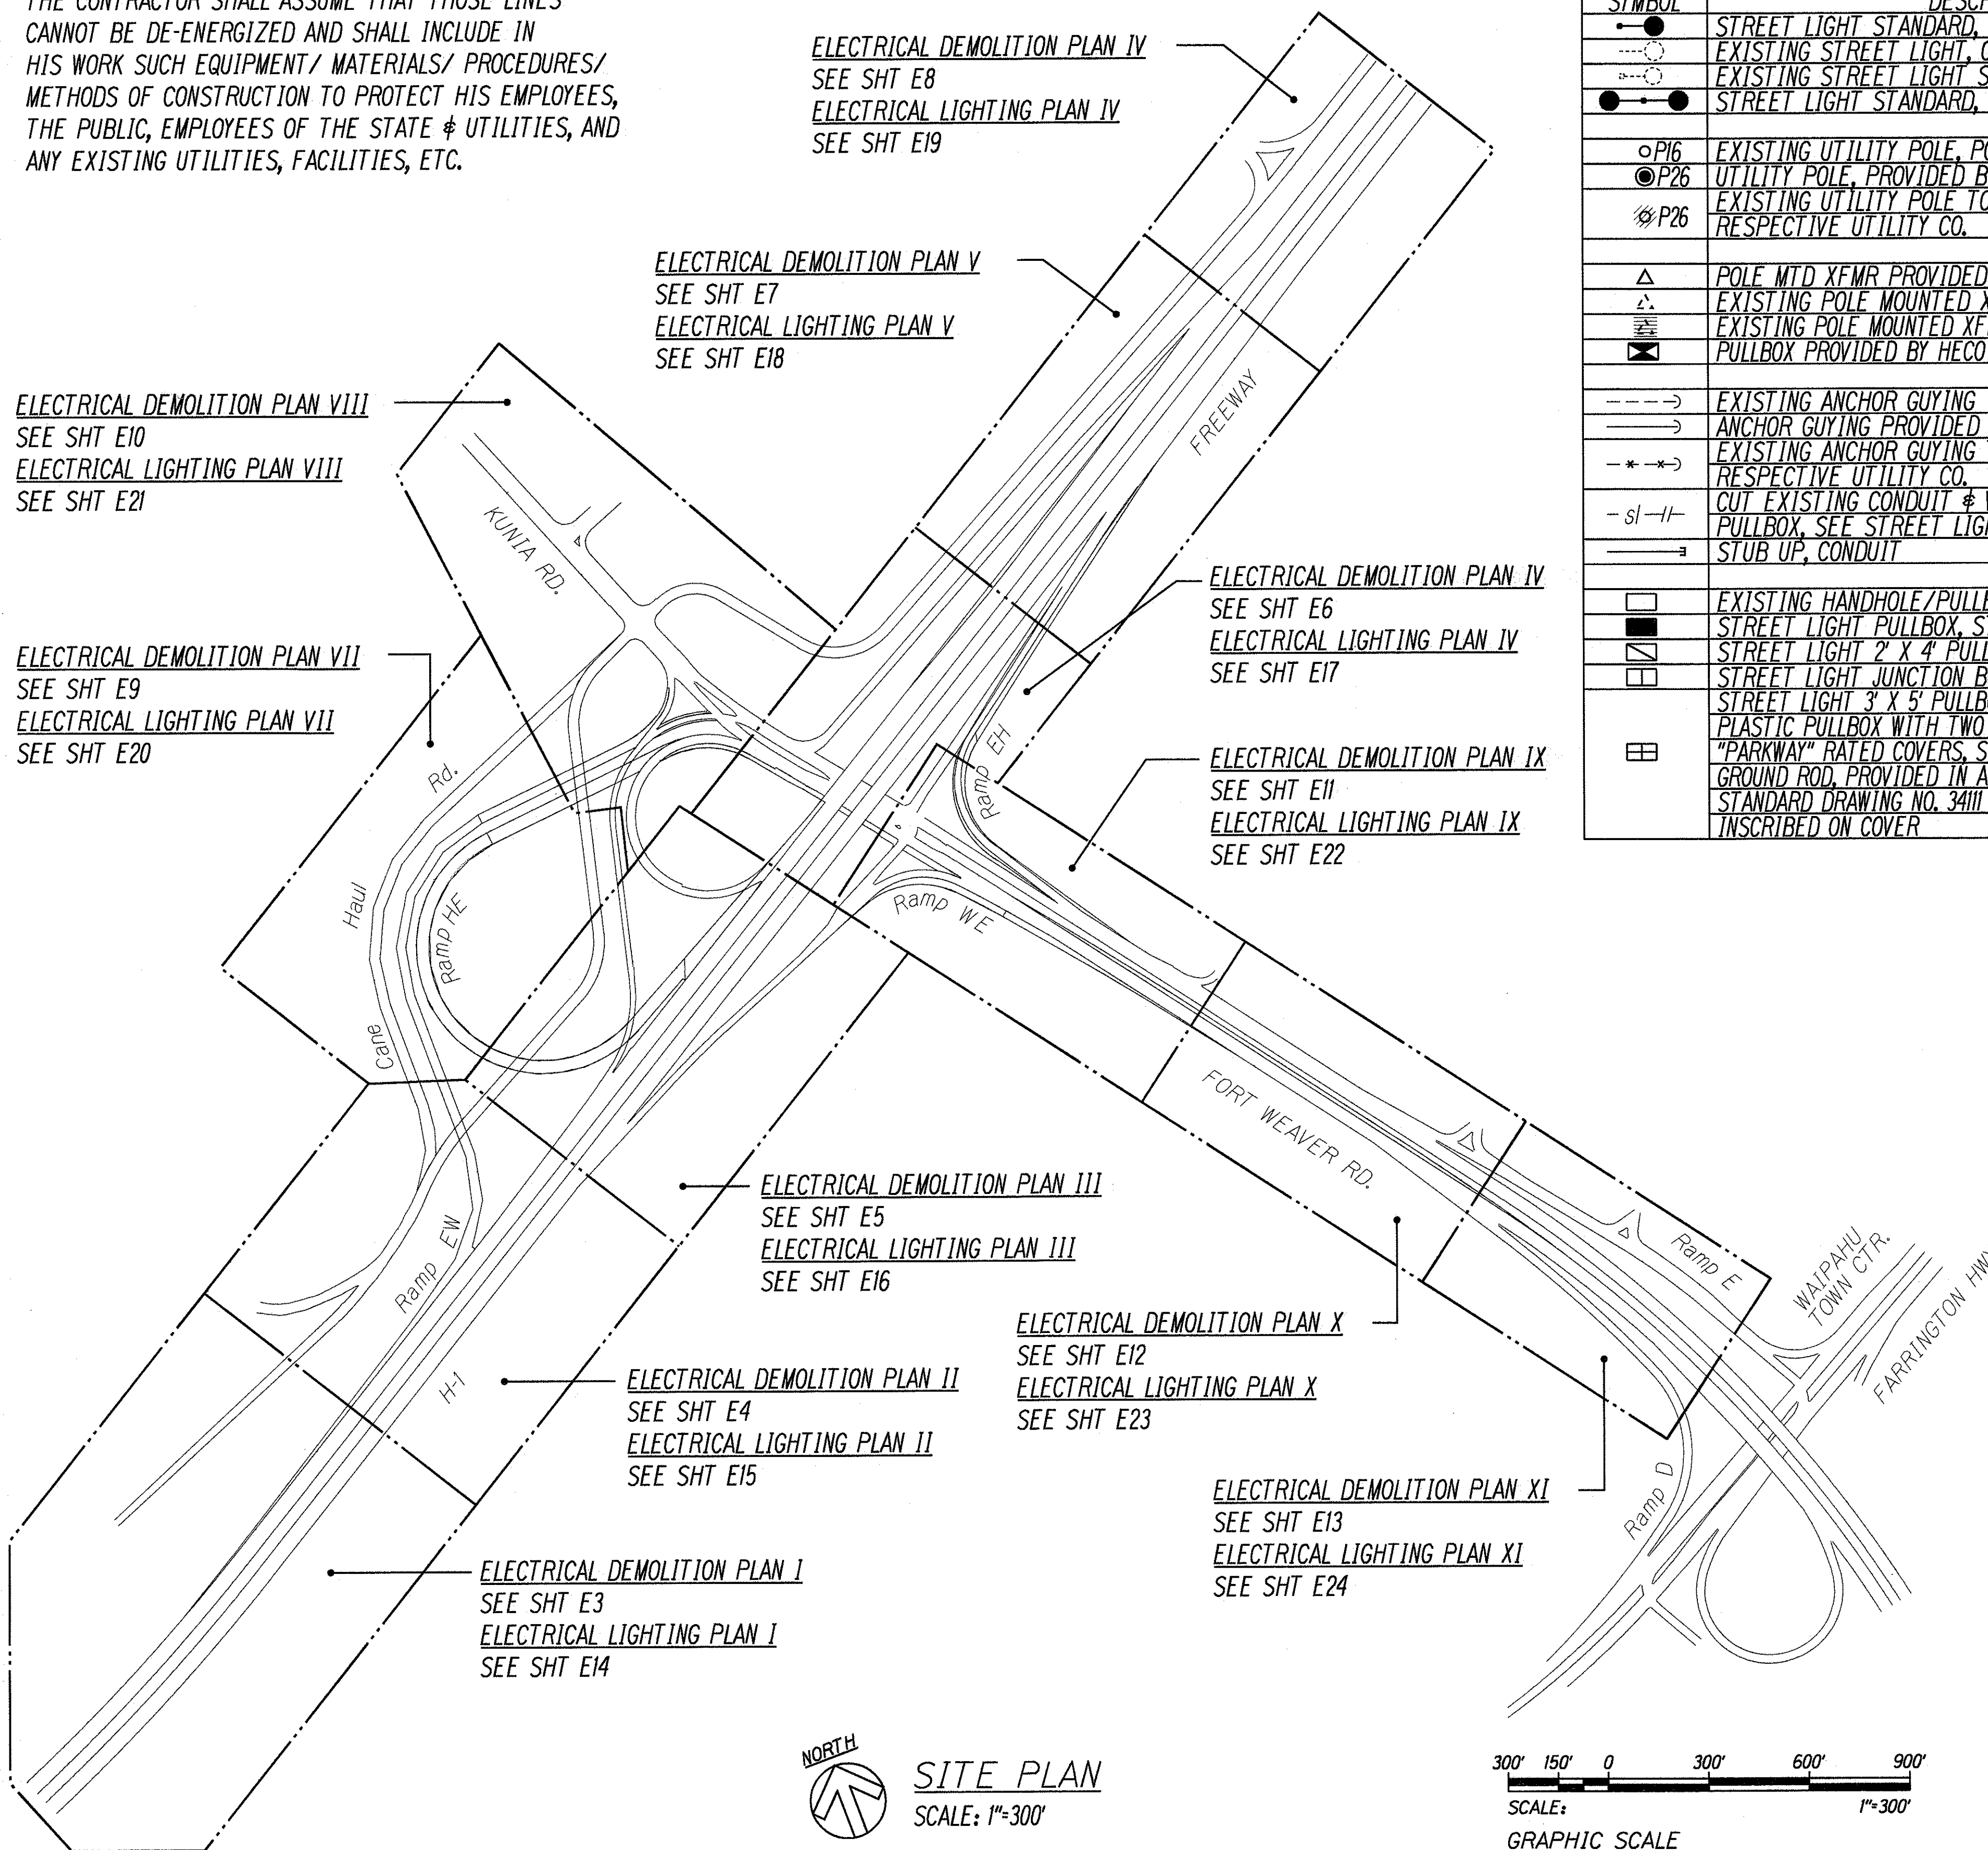


DATE	_____
SURVEY PLOTTED BY	_____
ORIGINAL PLAN	_____
TRACED BY	_____
DESIGNED BY	_____
CHECKED BY	_____
NOTE BOOK	_____
No.	_____

LAST SAVE: 10/01/97
C:\AD\PROJECTS\HAWAII\H1



SITE PLAN
SCALE: 1"=300'

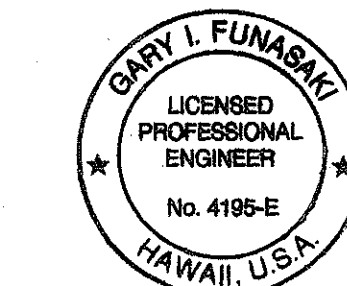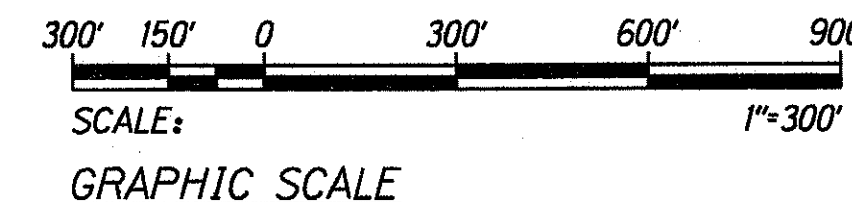

THIS WORK WAS PREPARED BY ME
OR UNDER MY SUPERVISION.
G. Funasaki
6 NOV 1997

STATE OF HAWAII
DEPARTMENT OF TRANSPORTATION
HIGHWAYS DIVISION

**ELECTRICAL SITE PLAN,
ELECTRICAL SYMBOLS**

INTERSTATE ROUTE H-1
Kuna Interchange Improvements
E.A.I. Project No 1M-HI-1(219)

SCALE: AS NOTED DATE: OCT. 1997

SHEET No. E1 OF 43 SHEETS

GENERAL ELECTRICAL NOTES

1. ALL ELECTRICAL WORK SHALL BE NEW UNLESS OTHERWISE NOTED.
2. THE LOCATIONS OF THE VARIOUS EXISTING UTILITIES SHOWN ON THE CONTRACT DRAWINGS WERE DETERMINED ON THE BASIS OF BEST AVAILABLE INFORMATION. THEREFORE, NO ASSURANCE IS PROVIDED THAT THE ACTUAL LOCATIONS WILL BE PRECISELY AS SHOWN ON THE CONTRACT DRAWINGS. THE CONTRACTOR SHALL BE HELD RESPONSIBLE FOR ANY DAMAGES TO THE FACILITIES.
3. IN PERFORMING ALL WORK, THE CONTRACTOR SHALL EXERCISE DUE CARE AND CAUTION NECESSARY TO AVOID ANY DAMAGE TO AND IMPAIRMENT IN THE USE OF ANY EXISTING UTILITY LINE. ANY DAMAGE INFLICTED ON EXISTING UTILITY LINES RESULTING FROM THE CONTRACTOR'S OPERATIONS SHALL BE IMMEDIATELY REPAIRED OR RESTORED AS DIRECTED BY THE STATE AT THE CONTRACTOR'S EXPENSE.
4. IF THE CONTRACTOR UNCOVERS AN ELECTRICAL LINE OF UNKNOWN ORIGIN/USAGE, HE SHALL IMMEDIATELY NOTIFY THE ENGINEER FOR DIRECTION.

HAWAIIAN ELECTRIC COMPANY (HECO) NOTES

1. THE LOCATION OF OVERHEAD AND UNDERGROUND FACILITIES SHOWN ON THE PLANS ARE FROM EXISTING RECORDS WITH VARYING DEGREES OF ACCURACY AND ARE NOT GUARANTEED AS SHOWN. THE CONTRACTOR SHALL EXERCISE EXTREME CAUTION WHEN THE EXCAVATION AND CONSTRUCTION CROSSES OR IS IN CLOSE PROXIMITY TO UNDERGROUND LINES AND SHALL MAINTAIN ADEQUATE CLEARANCE WHEN OPERATING EQUIPMENT WITHIN OR UNDER ANY OVERHEAD FACILITIES.
2. THE CONTRACTOR SHALL BE LIABLE FOR DAMAGES TO HECO'S FACILITIES AND SHALL IMMEDIATELY REPORT SUCH DAMAGES TO HECO'S TROUBLE DISPATCHER (543-7874).
3. FOR VERIFICATION OF UNDERGROUND LINES OR FOR ASSISTANCE IN SUPPORTING AND PROTECTING THESE LINES, THE CONTRACTOR SHALL CALL HECO'S UNDERGROUND DIVISION AT 543-7345 A MINIMUM OF 72 HOURS IN ADVANCE.
4. WHEN TRENCH EXCAVATION IS ADJACENT TO OR BENEATH HECO'S EXISTING STRUCTURES OR FACILITIES, THE CONTRACTOR IS RESPONSIBLE FOR:
 - a. SHEETING AND BRACING THE EXCAVATION TO PREVENT SLIDES, CAVE-INS, AND SETTLEMENTS.
 - b. PROTECTING EXISTING STRUCTURES OR FACILITIES WITH BEAMS, STRUTS, OR UNDER-PINNINGS.
5. FOR POLE BRACING INSTRUCTIONS, THE CONTRACTOR SHALL CALL THE HECO DISTRICT SUPERINTENDENT AT 543-4223 (WAI'AU) A MINIMUM OF 72 HOURS IN ADVANCE.
6. ALL HECO OVERHEAD AND UNDERGROUND FACILITIES SHALL BE PROTECTED AT ALL TIMES BY THE CONTRACTOR DURING CONSTRUCTION. COSTS FOR DAMAGES TO HECO FACILITIES SHALL BE BORNE BY THE CONTRACTOR. THIS REPAIR WORK SHALL BE DONE BY HECO, OR BY THE CONTRACTOR UNDER HECO'S SUPERVISION.
7. WORK TO BE DONE ON HECO FACILITIES SHALL BE UNDER THE DIRECT SUPERVISION OF A HECO'S INSPECTOR. THE CONTRACTOR SHALL NOTIFY THE CONSTRUCTION MANAGEMENT DEPARTMENT TWO WEEKS PRIOR TO WORK ON HAWAIIAN ELECTRIC CO. FACILITIES, AT 543-5668.
8. THE CONTRACTOR SHALL CALL HECO'S UNDERGROUND DIVISION (543-7345) A MINIMUM OF SEVENTY-TWO (72) HOURS IN ADVANCE FOR VERIFICATION OF UNDERGROUND LINES OR FOR ASSISTANCE IN SUPPORTING AND PROTECTING THESE LINES.

HAWAIIAN TELEPHONE COMPANY (HTCO) NOTES

1. THE LOCATION OF GTE HAWAIIAN TELEPHONE COMPANY'S EXISTING FACILITIES ARE APPROXIMATE ONLY. THE CONTRACTOR SHALL EXERCISE EXTREME CAUTION AND SHALL MAINTAIN PROPER CLEARANCES WHENEVER CONSTRUCTION CROSSES OR IS IN CLOSE PROXIMITY TO GTE HAWAIIAN TELEPHONE COMPANY'S FACILITIES. THE CONTRACTOR SHALL VERIFY THEIR LOCATIONS AND SHALL BE LIABLE FOR ANY DAMAGES TO GTE HAWAIIAN TELEPHONE COMPANY'S FACILITIES. ANY DAMAGES SHALL BE REPORTED IMMEDIATELY TO GTE HAWAIIAN TELEPHONE COMPANY'S REPAIR SECTION AT *611 (24 HOURS) OR TO THE EXCAVATION PERMIT SECTION AT 483-8085 (NORMAL WORK DAY HOURS, MONDAY THRU FRIDAY, EXCEPT HOLIDAYS).
2. FOR UNDERGROUND CABLE LOCATING AND MARKING, FIVE WORKING DAYS ADVANCE NOTICE IS REQUIRED. THREE WORKING DAYS ADVANCE NOTICE IS REQUIRED FOR ANY INSPECTION BY A DESIGNATED REPRESENTATIVE.
3. THE CONTRACTOR SHALL TAKE NECESSARY PRECAUTIONS NOT TO DAMAGE ANY EXISTING CABLES OR DUCTS. ANY WORK INVOLVING EXISTING GTE HAWAIIAN TELEPHONE COMPANY CABLES OR DUCTS SHALL BE DONE IN THE PRESENCE OF A GTE HAWAIIAN TEL INSPECTOR OR DESIGNATED REPRESENTATIVE.
4. THE CONTRACTOR SHALL OBTAIN AN EXCAVATION PERMIT AND TONING REQUEST FROM GTE HAWAIIAN TELEPHONE COMPANY'S EXCAVATION PERMIT SECTION, LOCATED AT 3239 UALENA STREET, THIRD FLOOR, TWO WEEKS PRIOR TO THE START OF CONSTRUCTION. HOURS OF BUSINESS ARE 7:00 AM TO 10:30 AM AND 11:30 AM TO 3:00 PM, MONDAY THRU FRIDAY, EXCEPT HOLIDAYS.
5. THE CONTRACTOR SHALL NOTIFY GTE HAWAIIAN TELEPHONE COMPANY'S INSPECTOR OR DESIGNATED REPRESENTATIVE 72 HOURS PRIOR TO EXCAVATION, BRACING OR BACKFILLING OF GTE HAWAIIAN TELEPHONE COMPANY'S STRUCTURES OR FACILITIES.
6. WHEN EXCAVATION IS ADJACENT TO OR BENEATH GTE HAWAIIAN TELEPHONE COMPANY'S EXISTING STRUCTURES OR FACILITIES, THE CONTRACTOR SHALL:
 - a. SHEET AND/OR BRACE THE EXCAVATION TO PREVENT SLIDES, CAVE-INS OR SETTLEMENTS TO ENSURE NO MOVEMENT TO GTE HAWAIIAN TELEPHONE COMPANY'S STRUCTURES OR FACILITIES.
 - b. PROTECT EXISTING STRUCTURES AND/OR FACILITIES WITH BEAMS, STRUTS OR UNDERPINNING WHILE EXCAVATING BENEATH THEM TO ENSURE NO MOVEMENT TO GTE HAWAIIAN TELEPHONE COMPANY'S STRUCTURES OR FACILITIES.

GENERAL STREET LIGHT NOTES

1. ALL EXISTING STREET LIGHTS SHALL REMAIN IN OPERATION UNTIL NEW STREET LIGHTS ARE IN PLACE AND ENERGIZED.
2. ALL EXISTING POLES, ARMS, LUMINAIRE AND HARDWARE REMOVED BY CONTRACTOR SHALL BE TRANSPORTED TO DOT BASEYARD AT 727 KAKOI STREET.


GENERAL NOTE

1. CONTRACTOR'S WORK NEAR UTILITY LINES AND POLES SHALL BE COORDINATED WITH RESPECTIVE UTILITY COMPANY.

FED. ROAD DIST. NO.	STATE	FED. AID PROJ. NO.	FISCAL YEAR	SHEET NO.	TOTAL SHEETS
HAWAII	HAW.	1M-HI-K(219)	1998	223	378

ORIGINAL PLAN	DATE
TRACED BY	
NOTED BY	
CHECKED BY	
NO.	

LAST SAVE 10/07/97 9:44:38 BY G. FULTON
G:\ROAD\PROJECTS\8808\10M-E2

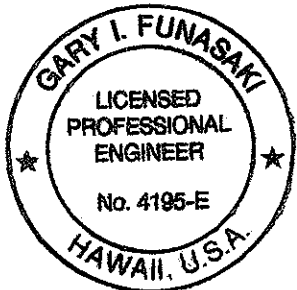

THIS WORK WAS PREPARED BY ME
OR UNDER MY SUPERVISION
6 NOV 1997

STATE OF HAWAII
DEPARTMENT OF TRANSPORTATION
HIGHWAYS DIVISION

GENERAL ELECTRICAL NOTES

INTERSTATE ROUTE H-1
Kunia Interchange Improvements
F.A.I. Project No. 1M-HI-K(219)


SCALE: NONE DATE: OCT. 1997
SHEET No. E2 OF 43 SHEETS

FED. ROAD DIST. NO.	STATE	FED. AID PROJ. NO.	FISCAL YEAR	SHEET NO.	TOTAL SHEETS
HAWAII	HAW.	1M-HI-1(219)	1998	225	378


NOTES:

- EXISTING UTILITY POLE TO BE REMOVED/RELOCATED BY RESPECTIVE UTILITY COMPANY.
- EXISTING ELECTRICAL/SIGNAL OVERHEAD LINES TO BE REMOVED/RELOCATED BY RESPECTIVE UTILITY COMPANY.
- UTILITY POLE P32 TO REMAIN AS RELOCATED. UTILITY POLE P31 TO REMAIN IN EXISTING LOCATION FOR USE BY HTCO. UTILITY POLE P30, AND ASSOCIATED OVERHEAD LINES, TO REMAIN TEMPORARILY DURING CONSTRUCTION TO MAINTAIN ELECTRICAL SERVICE TO EXISTING STREET LIGHT CONTROLLER "A". CONTRACTOR TO COORDINATE REMOVAL OF POLE P30 WITH HECO.

1/30/98	ADDED NOTE NO. 3 PER ADDENDUM NO. 2.
DATE	REVISION

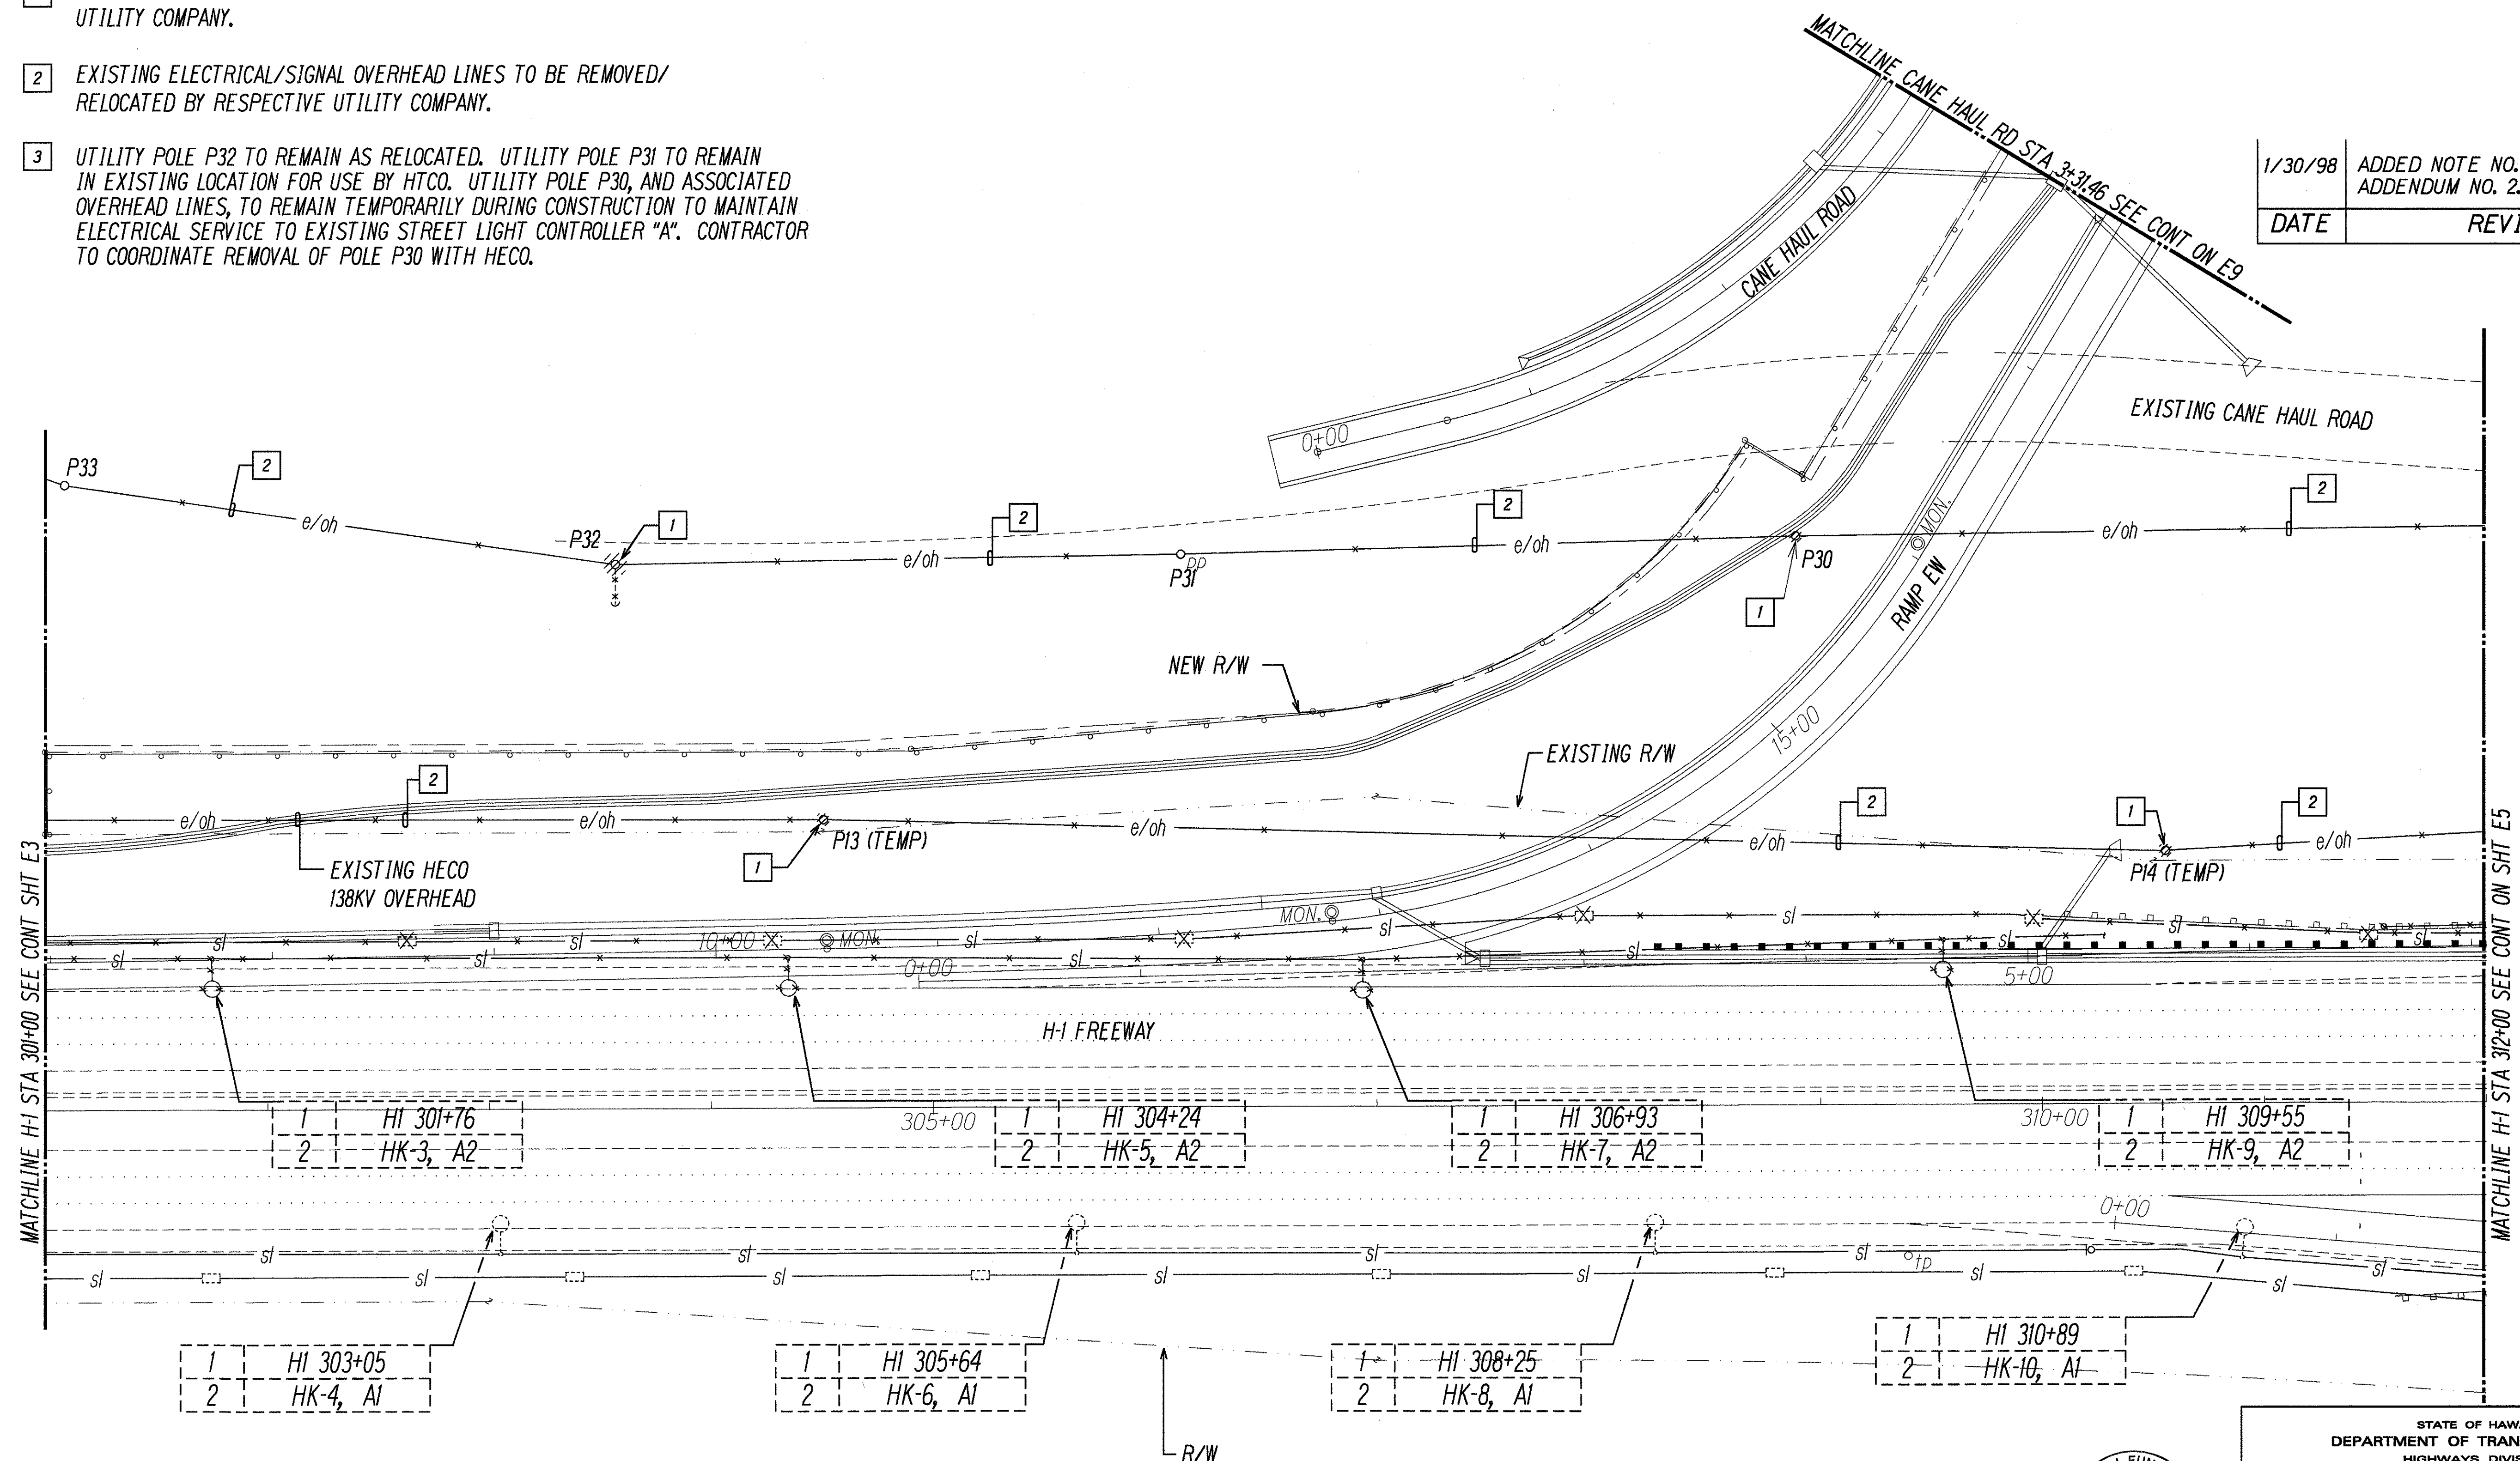

DATE	____
DESIGNED BY	____
CHECKED BY	____
NOTED BY	____
QUANTITIES BY	____
ORIGINAL PLAN	____
NOTE BOOK	____
CHECKED BY	____

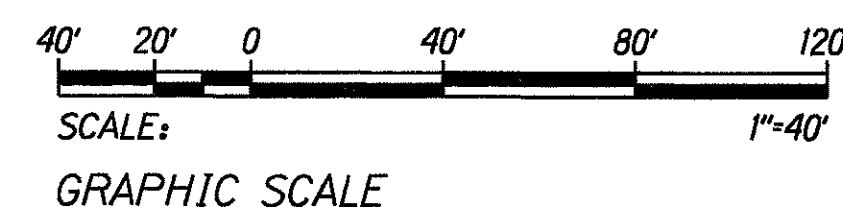

ELECTRICAL DEMOLITION PLAN - II

SCALE: 1"=40'



STATE OF HAWAII DEPARTMENT OF TRANSPORTATION HIGHWAYS DIVISION ELECTRICAL DEMOLITION PLAN - II

INTERSTATE ROUTE H-1
Kunia Interchange Improvements
F.A.I. Project No. 1M-HI-1(219)


SCALE: AS NOTED DATE: OCT. 1997
SHEET No. E4 OF 43 SHEETS

225R


FED. ROAD DIST. NO.	STATE	FED. AID PROJ. NO.	FISCAL YEAR	SHEET NO.	TOTAL SHEETS
HAWAII	HAW.	1M-HI-K(219)	1998	226	378

NOTES:


- 1 REMOVE EXISTING STREET LIGHT CONTROLLER "A" AND FOUNDATION.
- 2 EXISTING UTILITY POLE TO BE REMOVED/RELOCATED BY HECO.
- 3 EXISTING ELECTRICAL/SIGNAL OVERHEAD LINES TO BE REMOVED/RELOCATED BY RESPECTIVE UTILITY COMPANY.
- 4 REMOVE EXISTING WIRING, ABANDON CONDUIT IN PLACE.
- 5 UTILITY POLES P27, P28 AND P29, AND ASSOCIATED OVERHEAD LINES TO REMAIN TEMPORARILY DURING CONSTRUCTION TO MAINTAIN ELECTRICAL SERVICE TO EXISTING STREET LIGHT CONTROLLER "A". CONTRACTOR TO COORDINATE REMOVAL OF POLES WITH HECO.

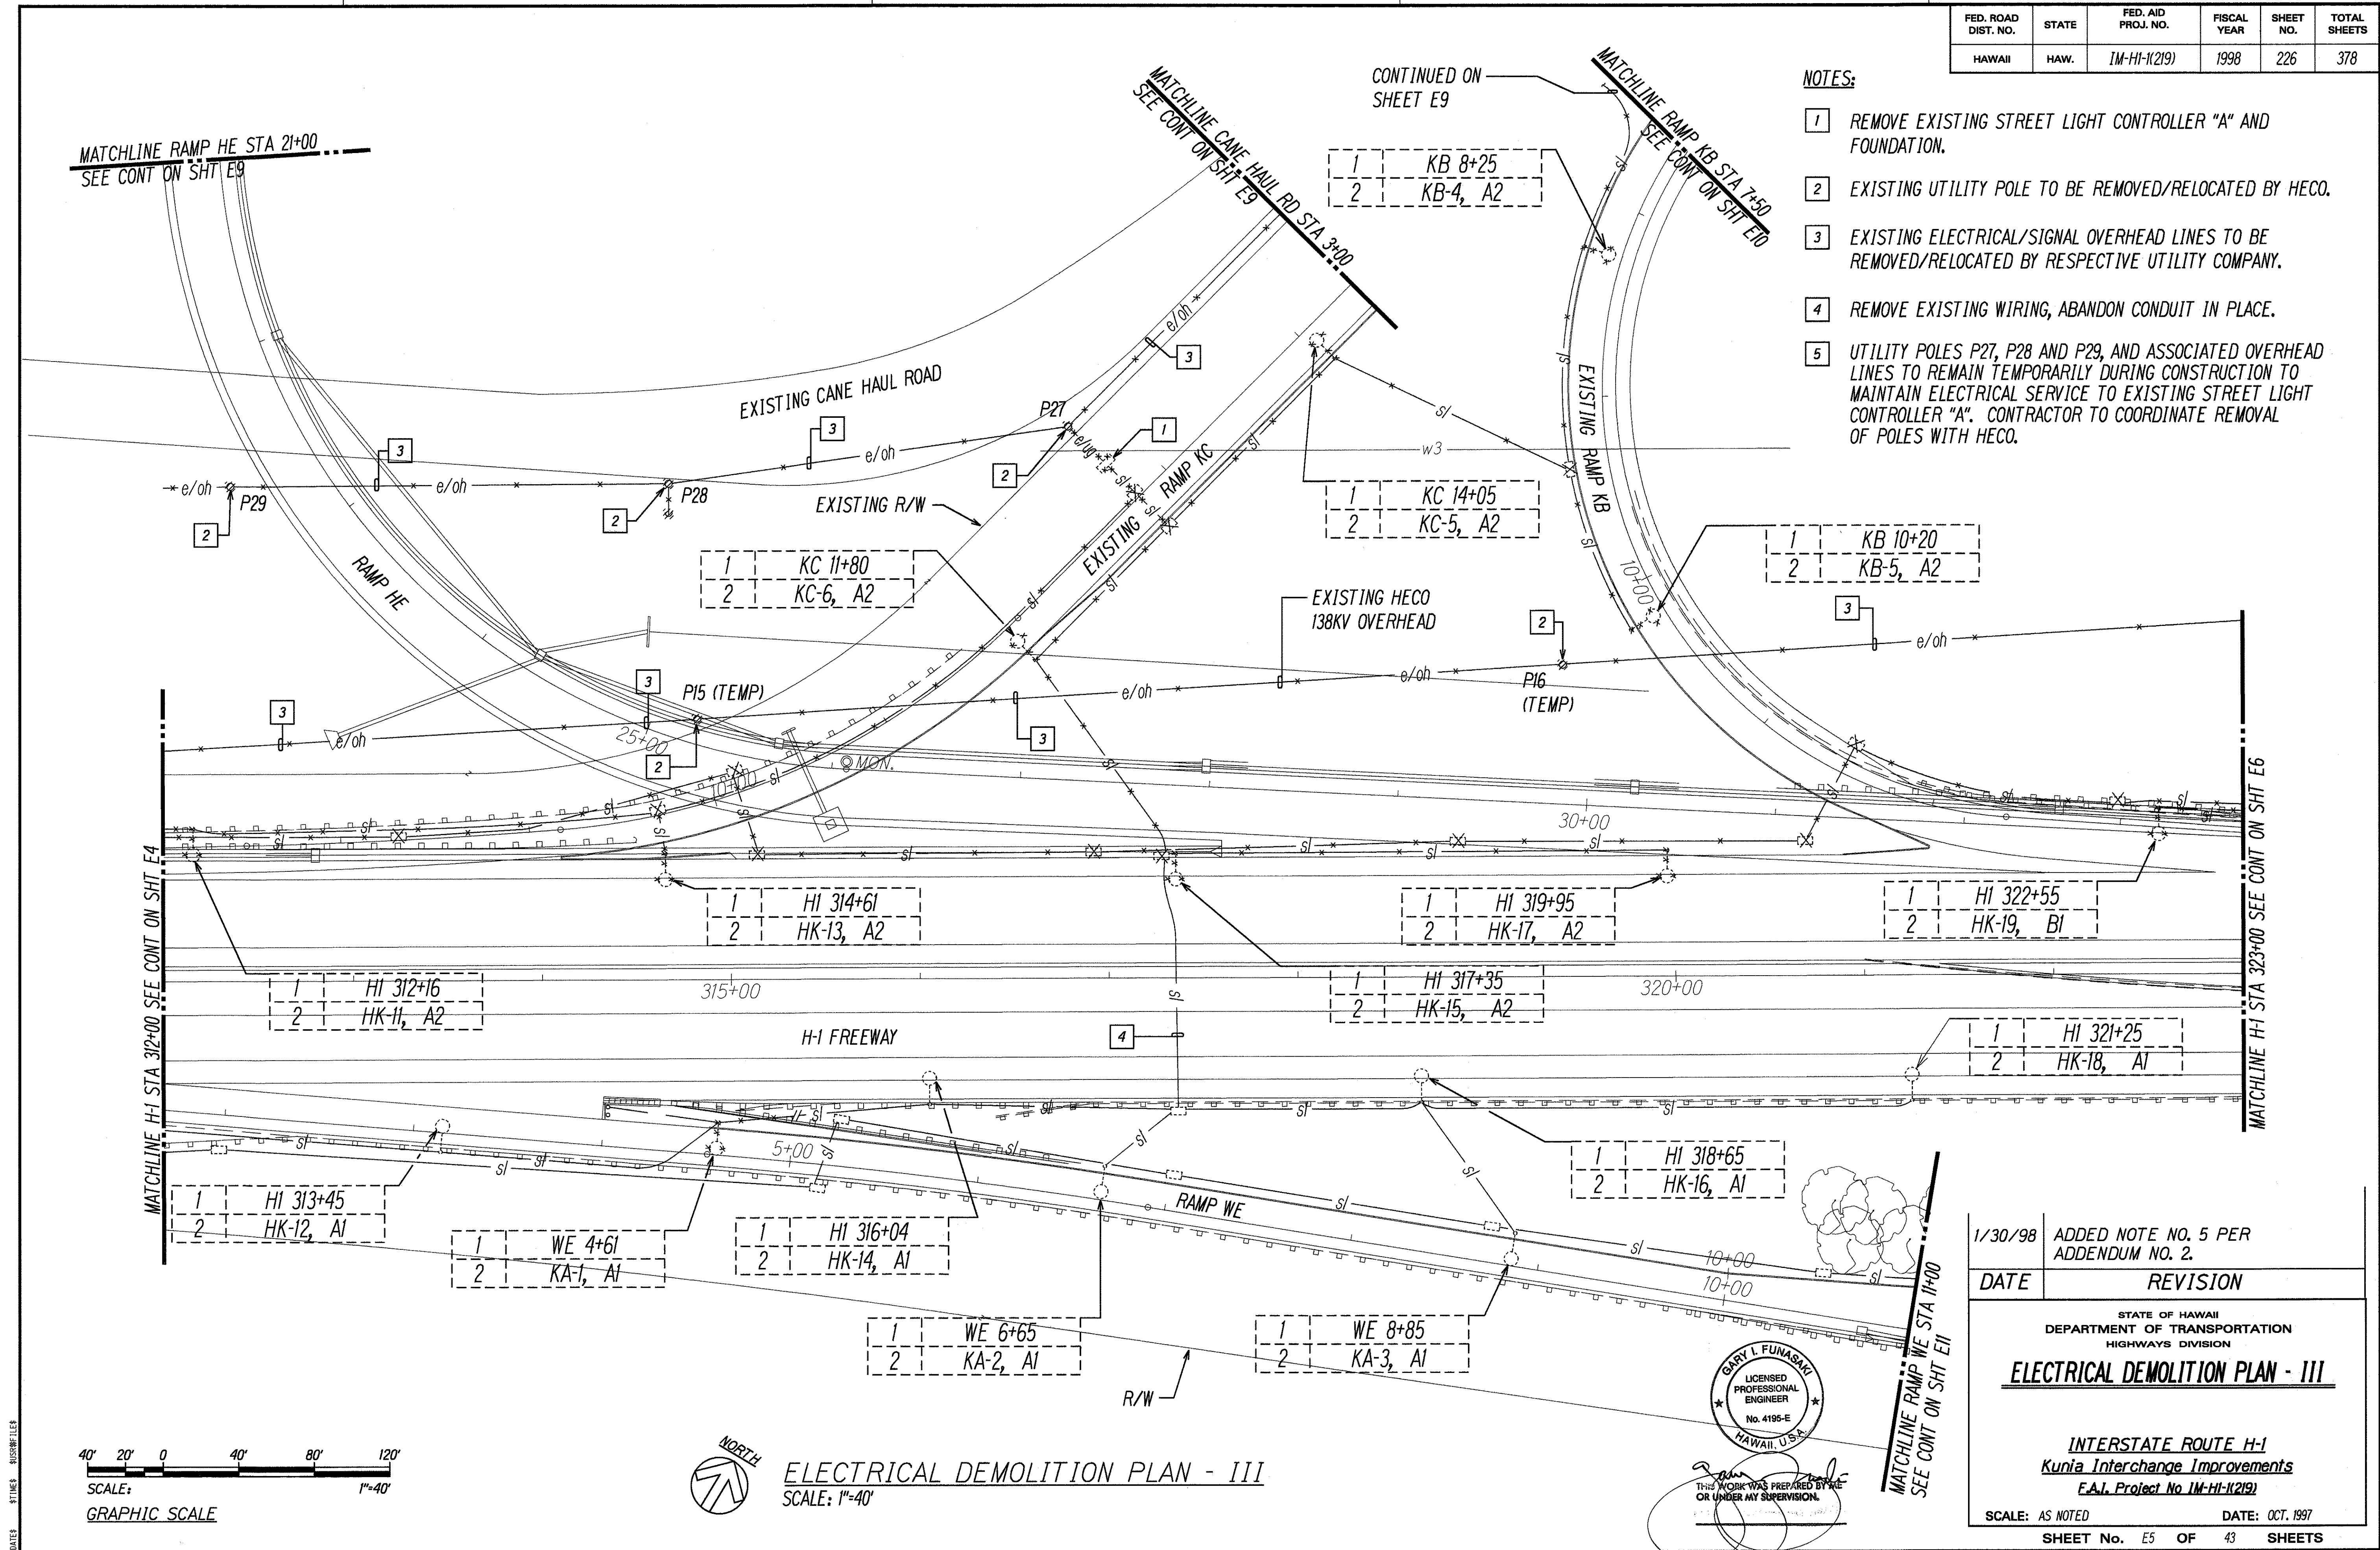

FED. ROAD DIST. NO.	STATE	FED. AID PROJ. NO.	FISCAL YEAR	SHEET NO.	TOTAL SHEETS
HAWAII	HAW.	1M-HI-K(219)	1998	228	378

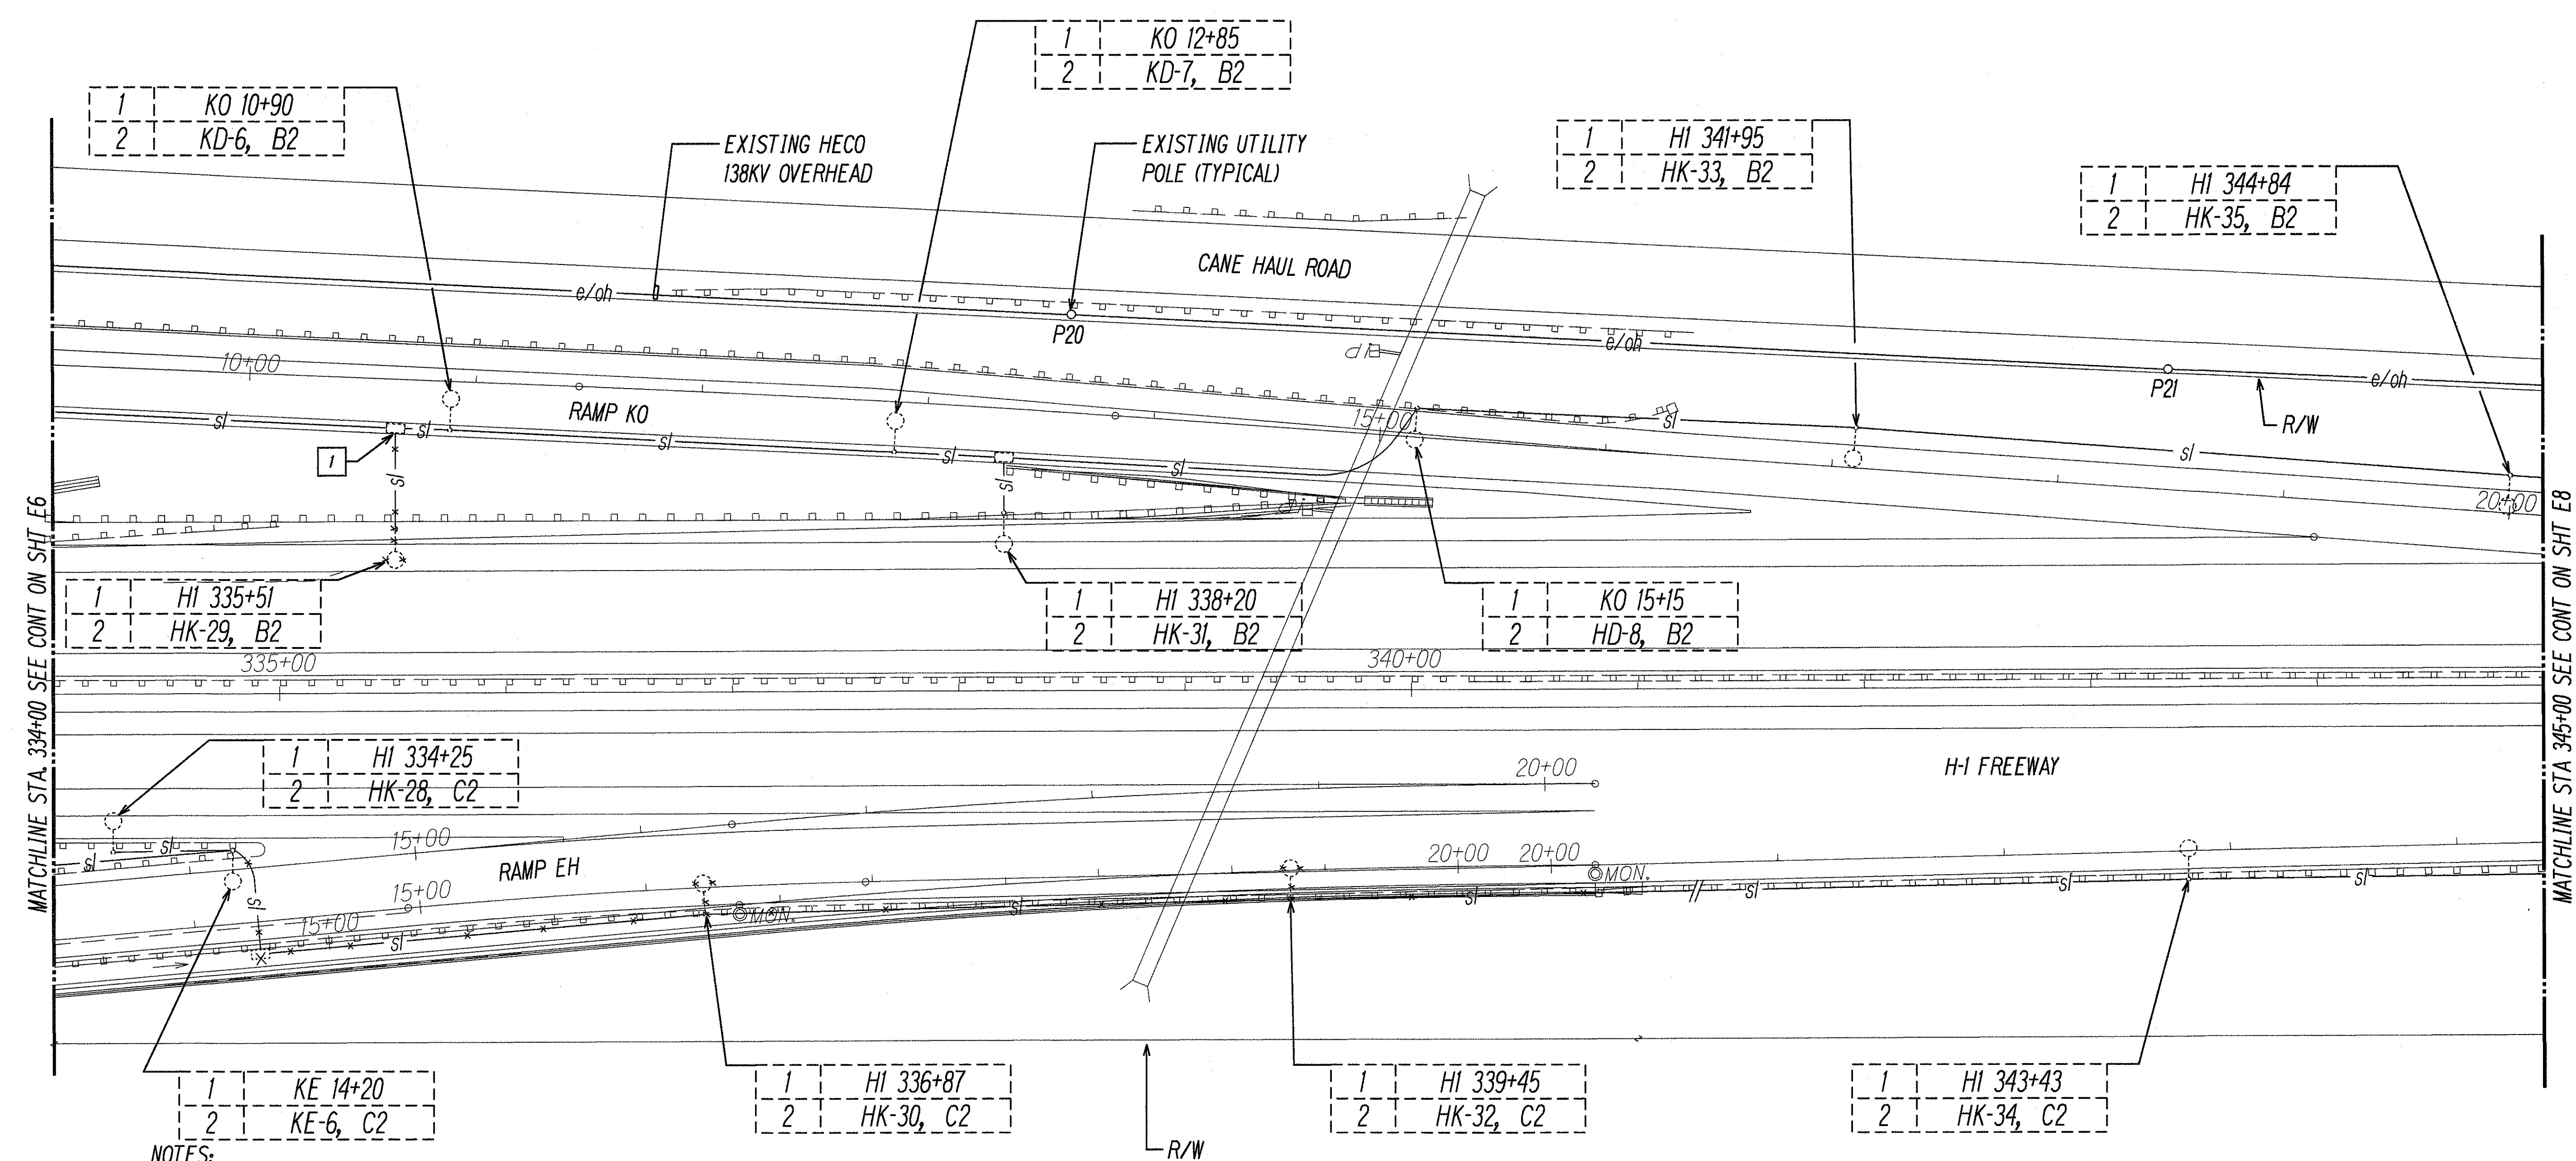

NOTES:
 1 CUT & CAP EXISTING CABLE IN PULLBOX.

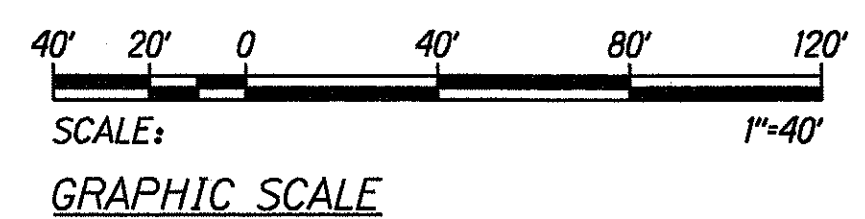

ELECTRICAL DEMOLITION PLAN - V
 SCALE: 1"=40'



STATE OF HAWAII
 DEPARTMENT OF TRANSPORTATION
 HIGHWAYS DIVISION

ELECTRICAL DEMOLITION PLAN - V

INTERSTATE ROUTE H-1
 Kunia Interchange Improvements
 F.A.I. Project No 1M-HI-K(219)


SCALE: AS NOTED DATE: OCT. 1997
 SHEET No. E7 OF 43 SHEETS

SURVEY PLOTTED BY	DATE
DRAWN BY	
CHECKED BY	
NOTE BOOK	
CHECKED BY	

LAST SHEET 10/10/97 & 10/10/97 BY G.I.F. NO. 10/10/97
 G.I.F. PROJECTS 10/10/97

THIS WORK WAS PREPARED BY ME
 OR UNDER MY SUPERVISION.
 6 Nov 1997


FED. ROAD DIST. NO.	STATE	FED. AID PROJ. NO.	FISCAL YEAR	SHEET NO.	TOTAL SHEETS
HAWAII	HAW.	1M-HI-(219)	1998	230	378

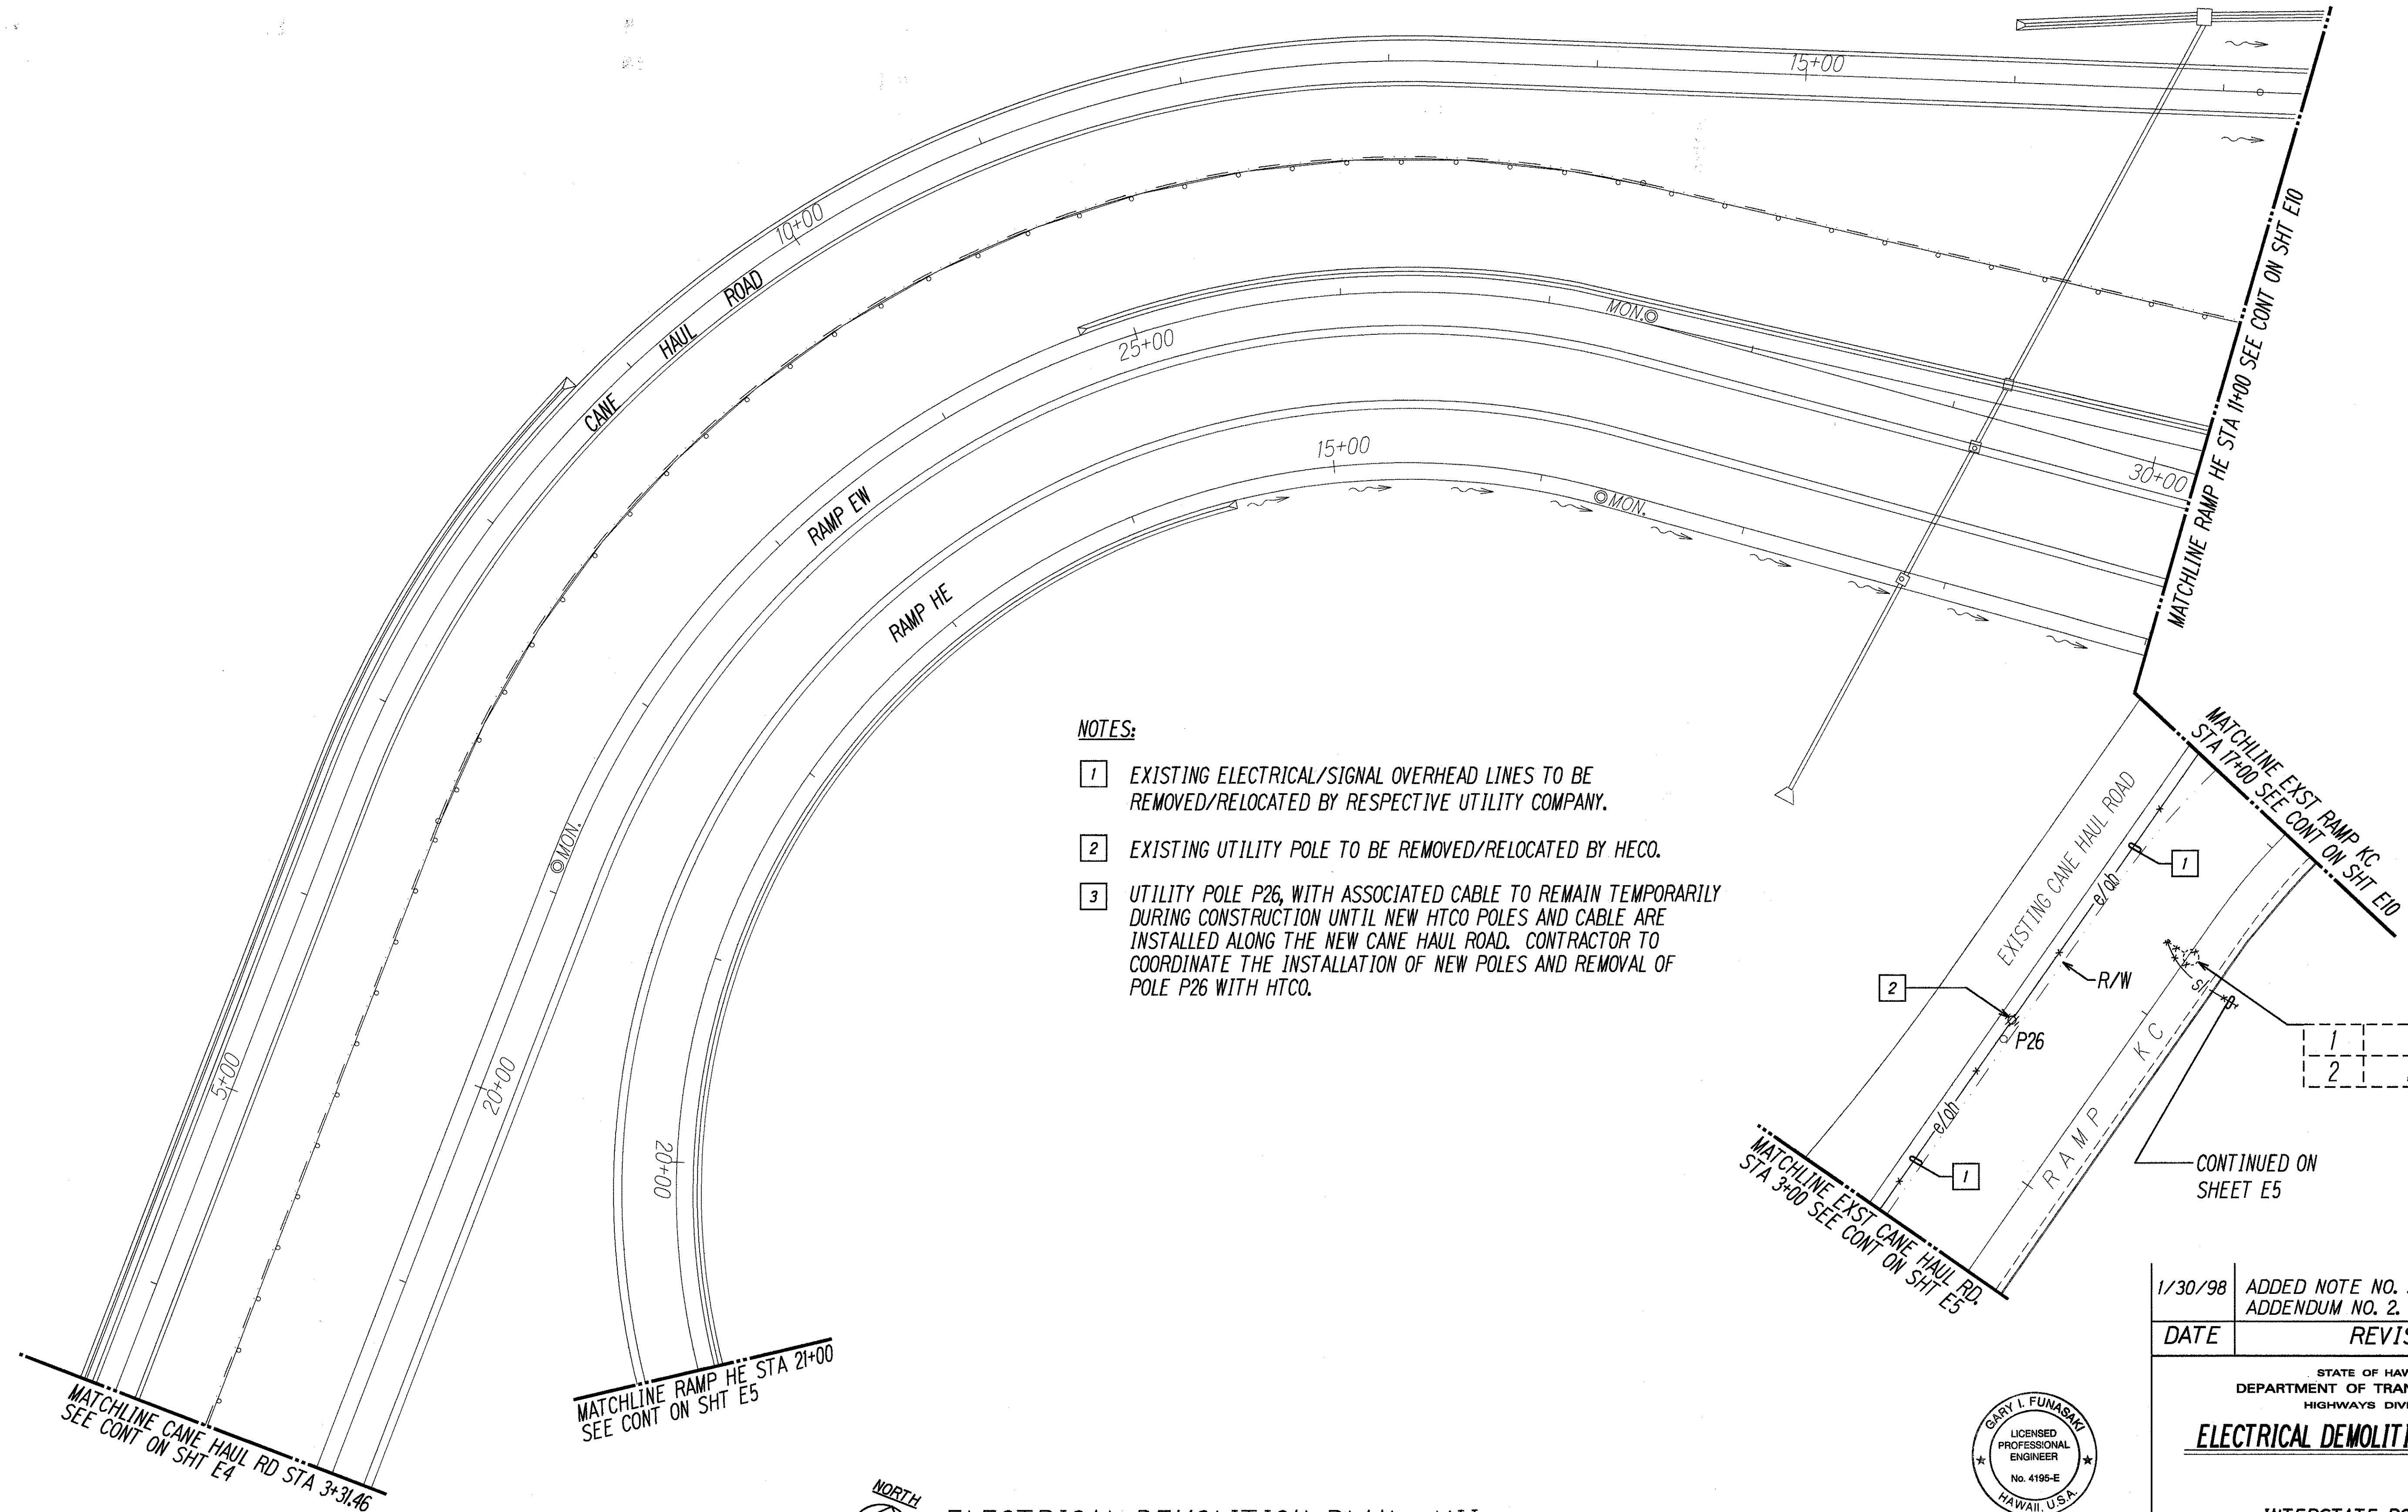

- NOTES:**
- 1 EXISTING ELECTRICAL/SIGNAL OVERHEAD LINES TO BE REMOVED/RELOCATED BY RESPECTIVE UTILITY COMPANY.
 - 2 EXISTING UTILITY POLE TO BE REMOVED/RELOCATED BY HECO.
 - 3 UTILITY POLE P26, WITH ASSOCIATED CABLE TO REMAIN TEMPORARILY DURING CONSTRUCTION UNTIL NEW HTCO POLES AND CABLE ARE INSTALLED ALONG THE NEW CANE HAUL ROAD. CONTRACTOR TO COORDINATE THE INSTALLATION OF NEW POLES AND REMOVAL OF POLE P26 WITH HTCO.

1	KC 16+35
2	KC-4, A2

SURVEY PLOTTED BY	DATE
DRAWN BY	
DESIGNED BY	
QUANTITIES BY	
CHECKED BY	
ORIGINAL PLAN	
NOTE BOOK	
NO.	

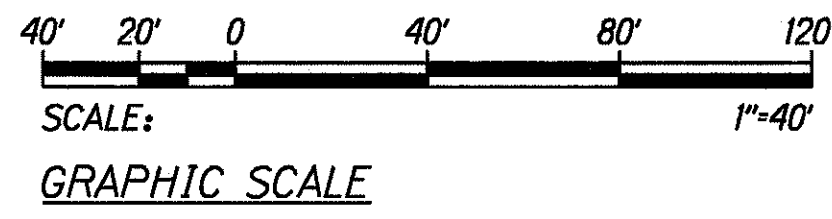

ELECTRICAL DEMOLITION PLAN - VII
SCALE: 1"=40'

THIS WORK WAS PREPARED BY ME OR UNDER MY SUPERVISION.

1/30/98	ADDED NOTE NO. 3 PER ADDENDUM NO. 2.
DATE	REVISION

STATE OF HAWAII
DEPARTMENT OF TRANSPORTATION
HIGHWAYS DIVISION


ELECTRICAL DEMOLITION PLAN - VII

INTERSTATE ROUTE H-1
Kunia Interchange Improvements
F.A.I. Project No. 1M-HI-(219)


SCALE: AS NOTED DATE: OCT. 1997

SHEET No. E9 OF 43 SHEETS

FED. ROAD DIST. NO.	STATE	FED. AID PROJ. NO.	FISCAL YEAR	SHEET NO.	TOTAL SHEETS
HAWAII	HAW.	1M-HI-K219	1998	231	378

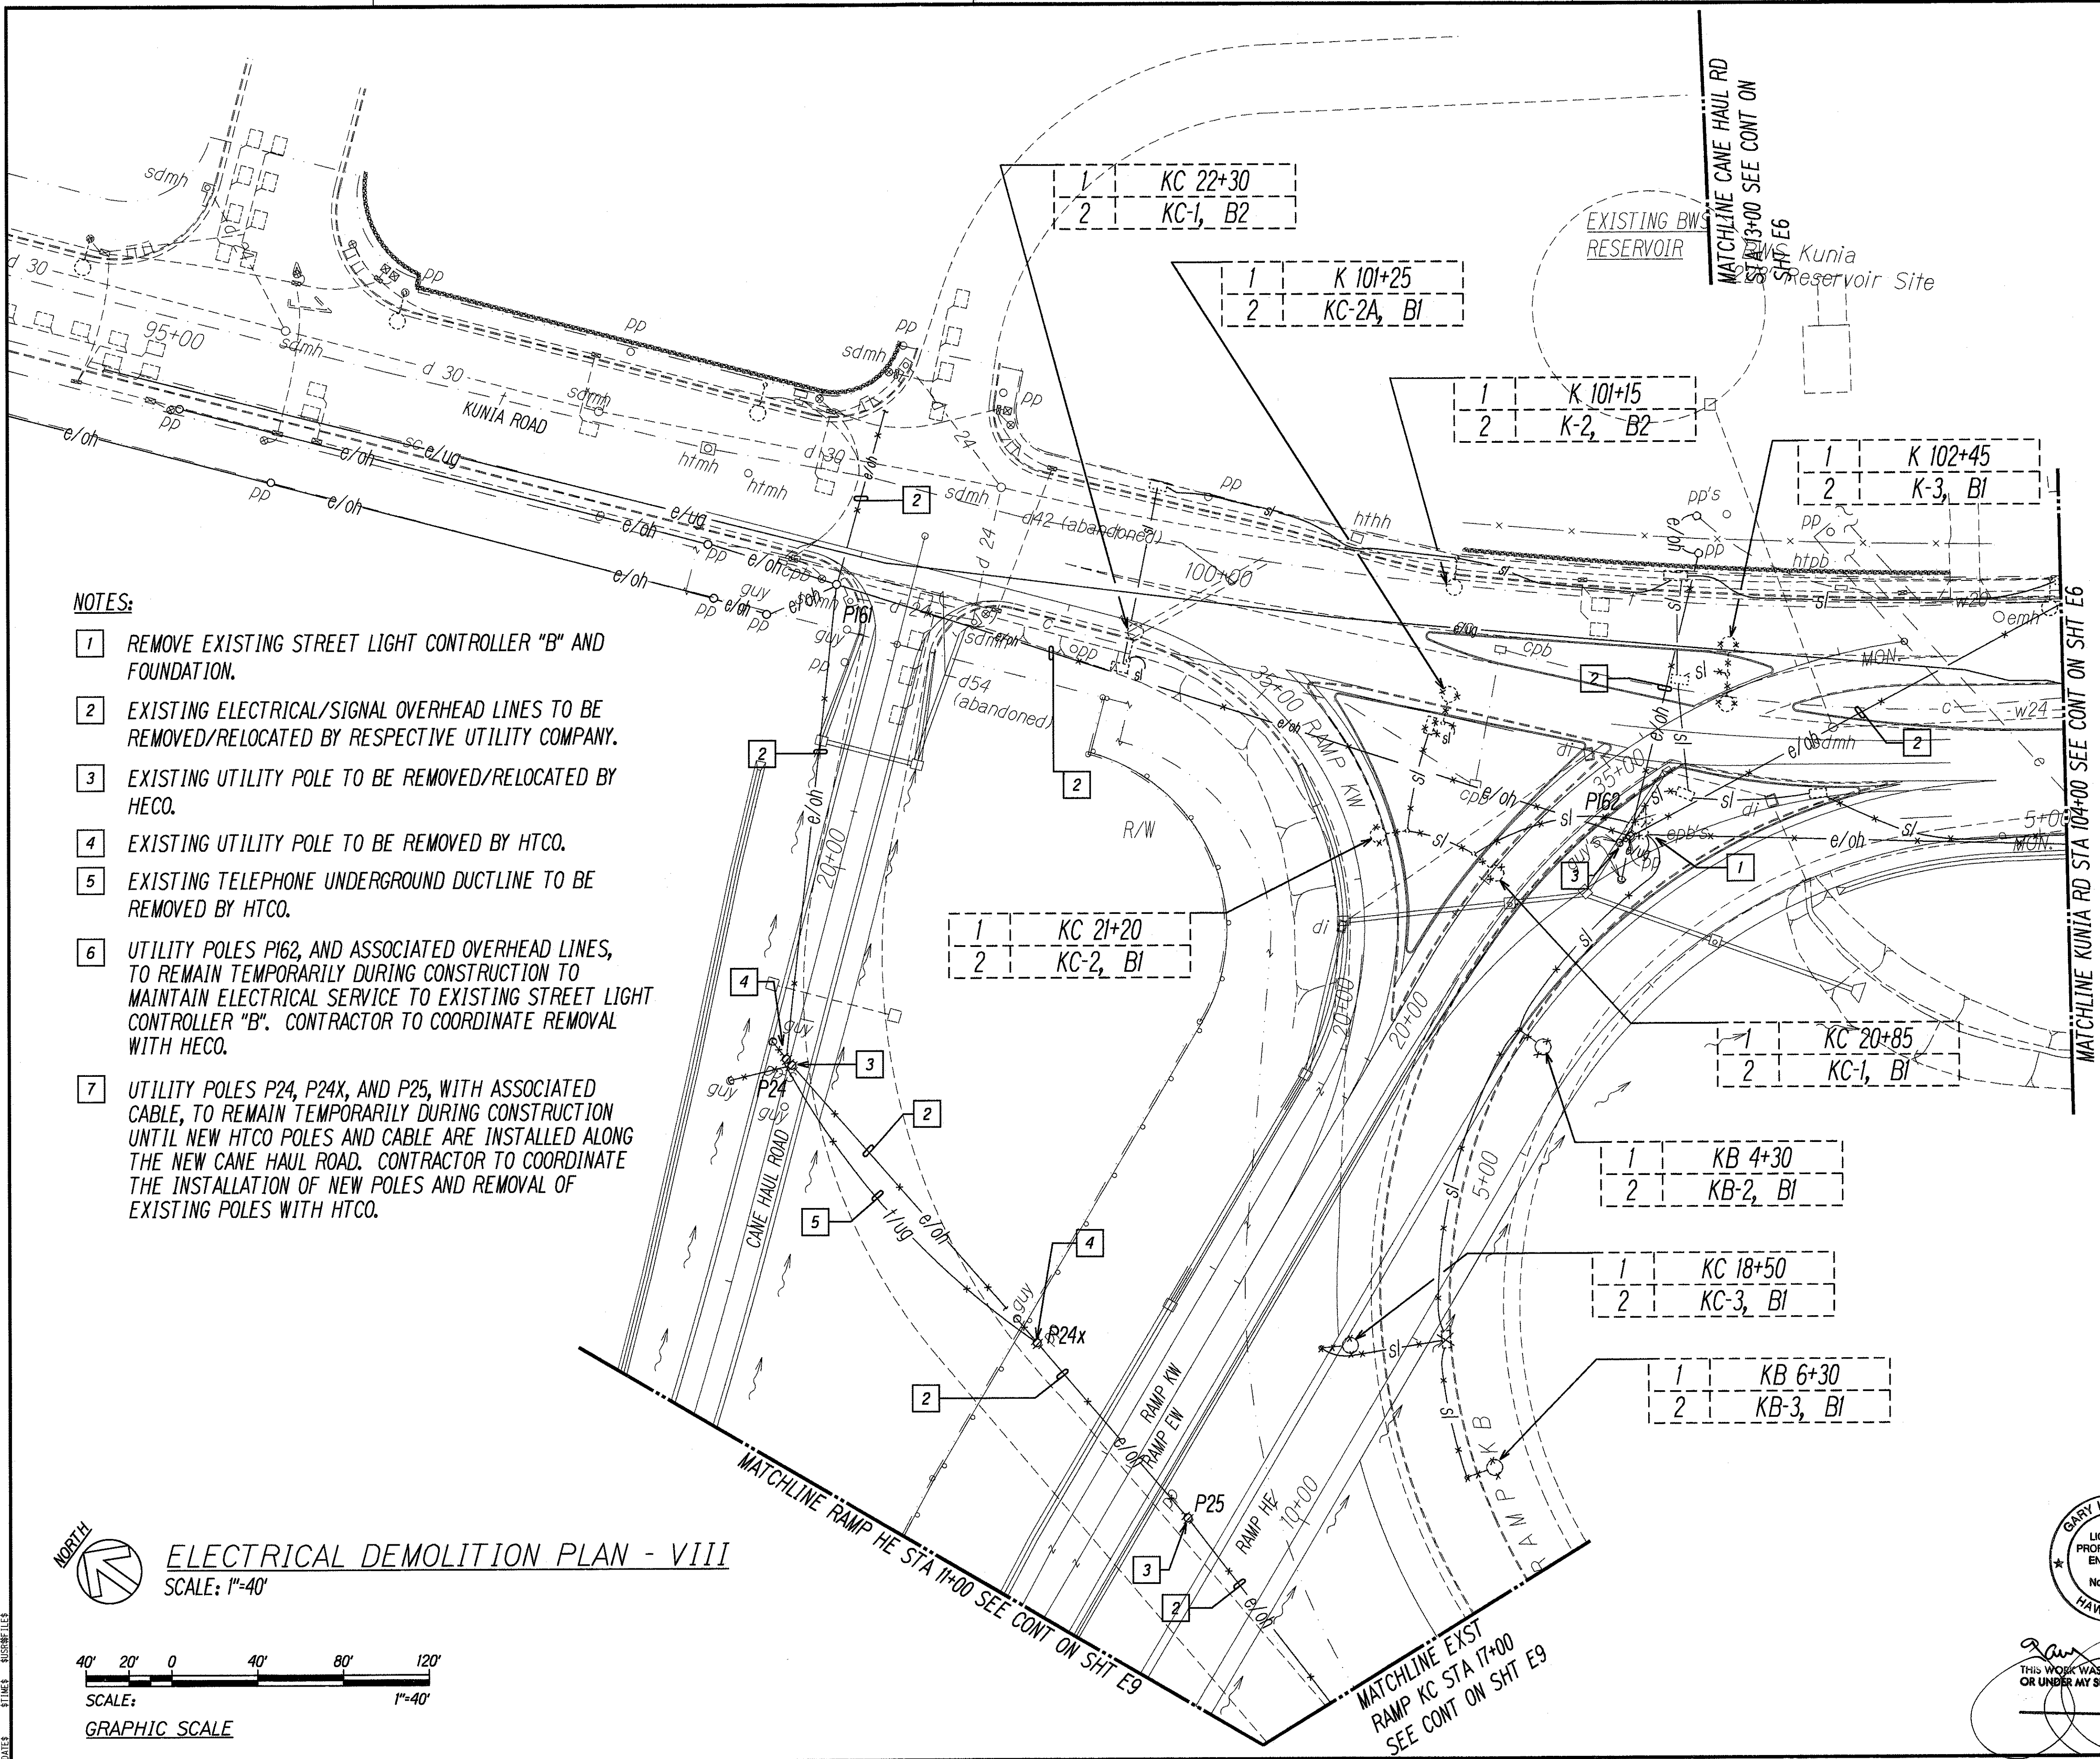

SURVEY PLOTTED BY	DATE
DESIGNED BY	
CHECKED BY	
ORIGINAL PLAN	
NOTE BOOK	
CHECKED BY	

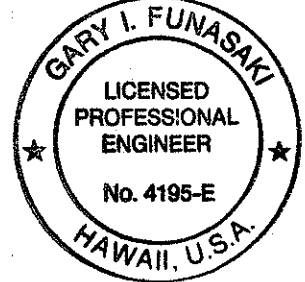



THIS WORK WAS PREPARED BY ME OR UNDER MY SUPERVISION.

1/30/98	ADDED NOTE NOS. 6, & 7 PER ADDENDUM NO. 2.
DATE	REVISION
STATE OF HAWAII DEPARTMENT OF TRANSPORTATION HIGHWAYS DIVISION	
ELECTRICAL DEMOLITION PLAN - VIII	
INTERSTATE ROUTE H-1 Kunia Interchange Improvements F.A.I. Project No 1M-HI-K219	
SCALE: AS NOTED	DATE: OCT. 1997
SHEET No. E10 OF 43 SHEETS	

FED. ROAD DIST. NO.	STATE	FED. AID PROJ. NO.	FISCAL YEAR	SHEET NO.	TOTAL SHEETS
HAWAII	HAW.	1M-HI-1(219)	1998	232	378



NOTES:

- 1 REMOVE EXISTING STREET LIGHT CONTROLLER "C" AND FOUNDATION.
- 2 EXISTING ELECTRICAL/SIGNAL OVERHEAD LINES TO BE REMOVED/RELOCATED BY RESPECTIVE UTILITY COMPANY.
- 3 EXISTING UTILITY POLE TO BE REMOVED/RELOCATED BY RESPECTIVE UTILITY CO.
- 4 EXISTING UTILITY PULLBOX TO BE REMOVED BY HECO.
- 5 UTILITY POLE PI65, AND ASSOCIATED OVERHEAD LINES, TO REMAIN TEMPORARILY DURING CONSTRUCTION TO MAINTAIN ELECTRICAL SERVICE TO EXISTING STREET LIGHT CONTROLLER "C". CONTRACTOR TO COORDINATE REMOVAL OF POLES WITH HECO.
- 6 UTILITY POLE PI/166 TO REMAIN IN PLACE WITH THE ANCHOR REMOVED.
- 7 HTCO TO RELOCATE UTILITY POLE P45 AT ENTRANCE TO RAMP EH DURING CONSTRUCTION. CONTRACTOR TO REMOVAL WITH HTCO.

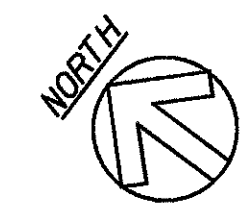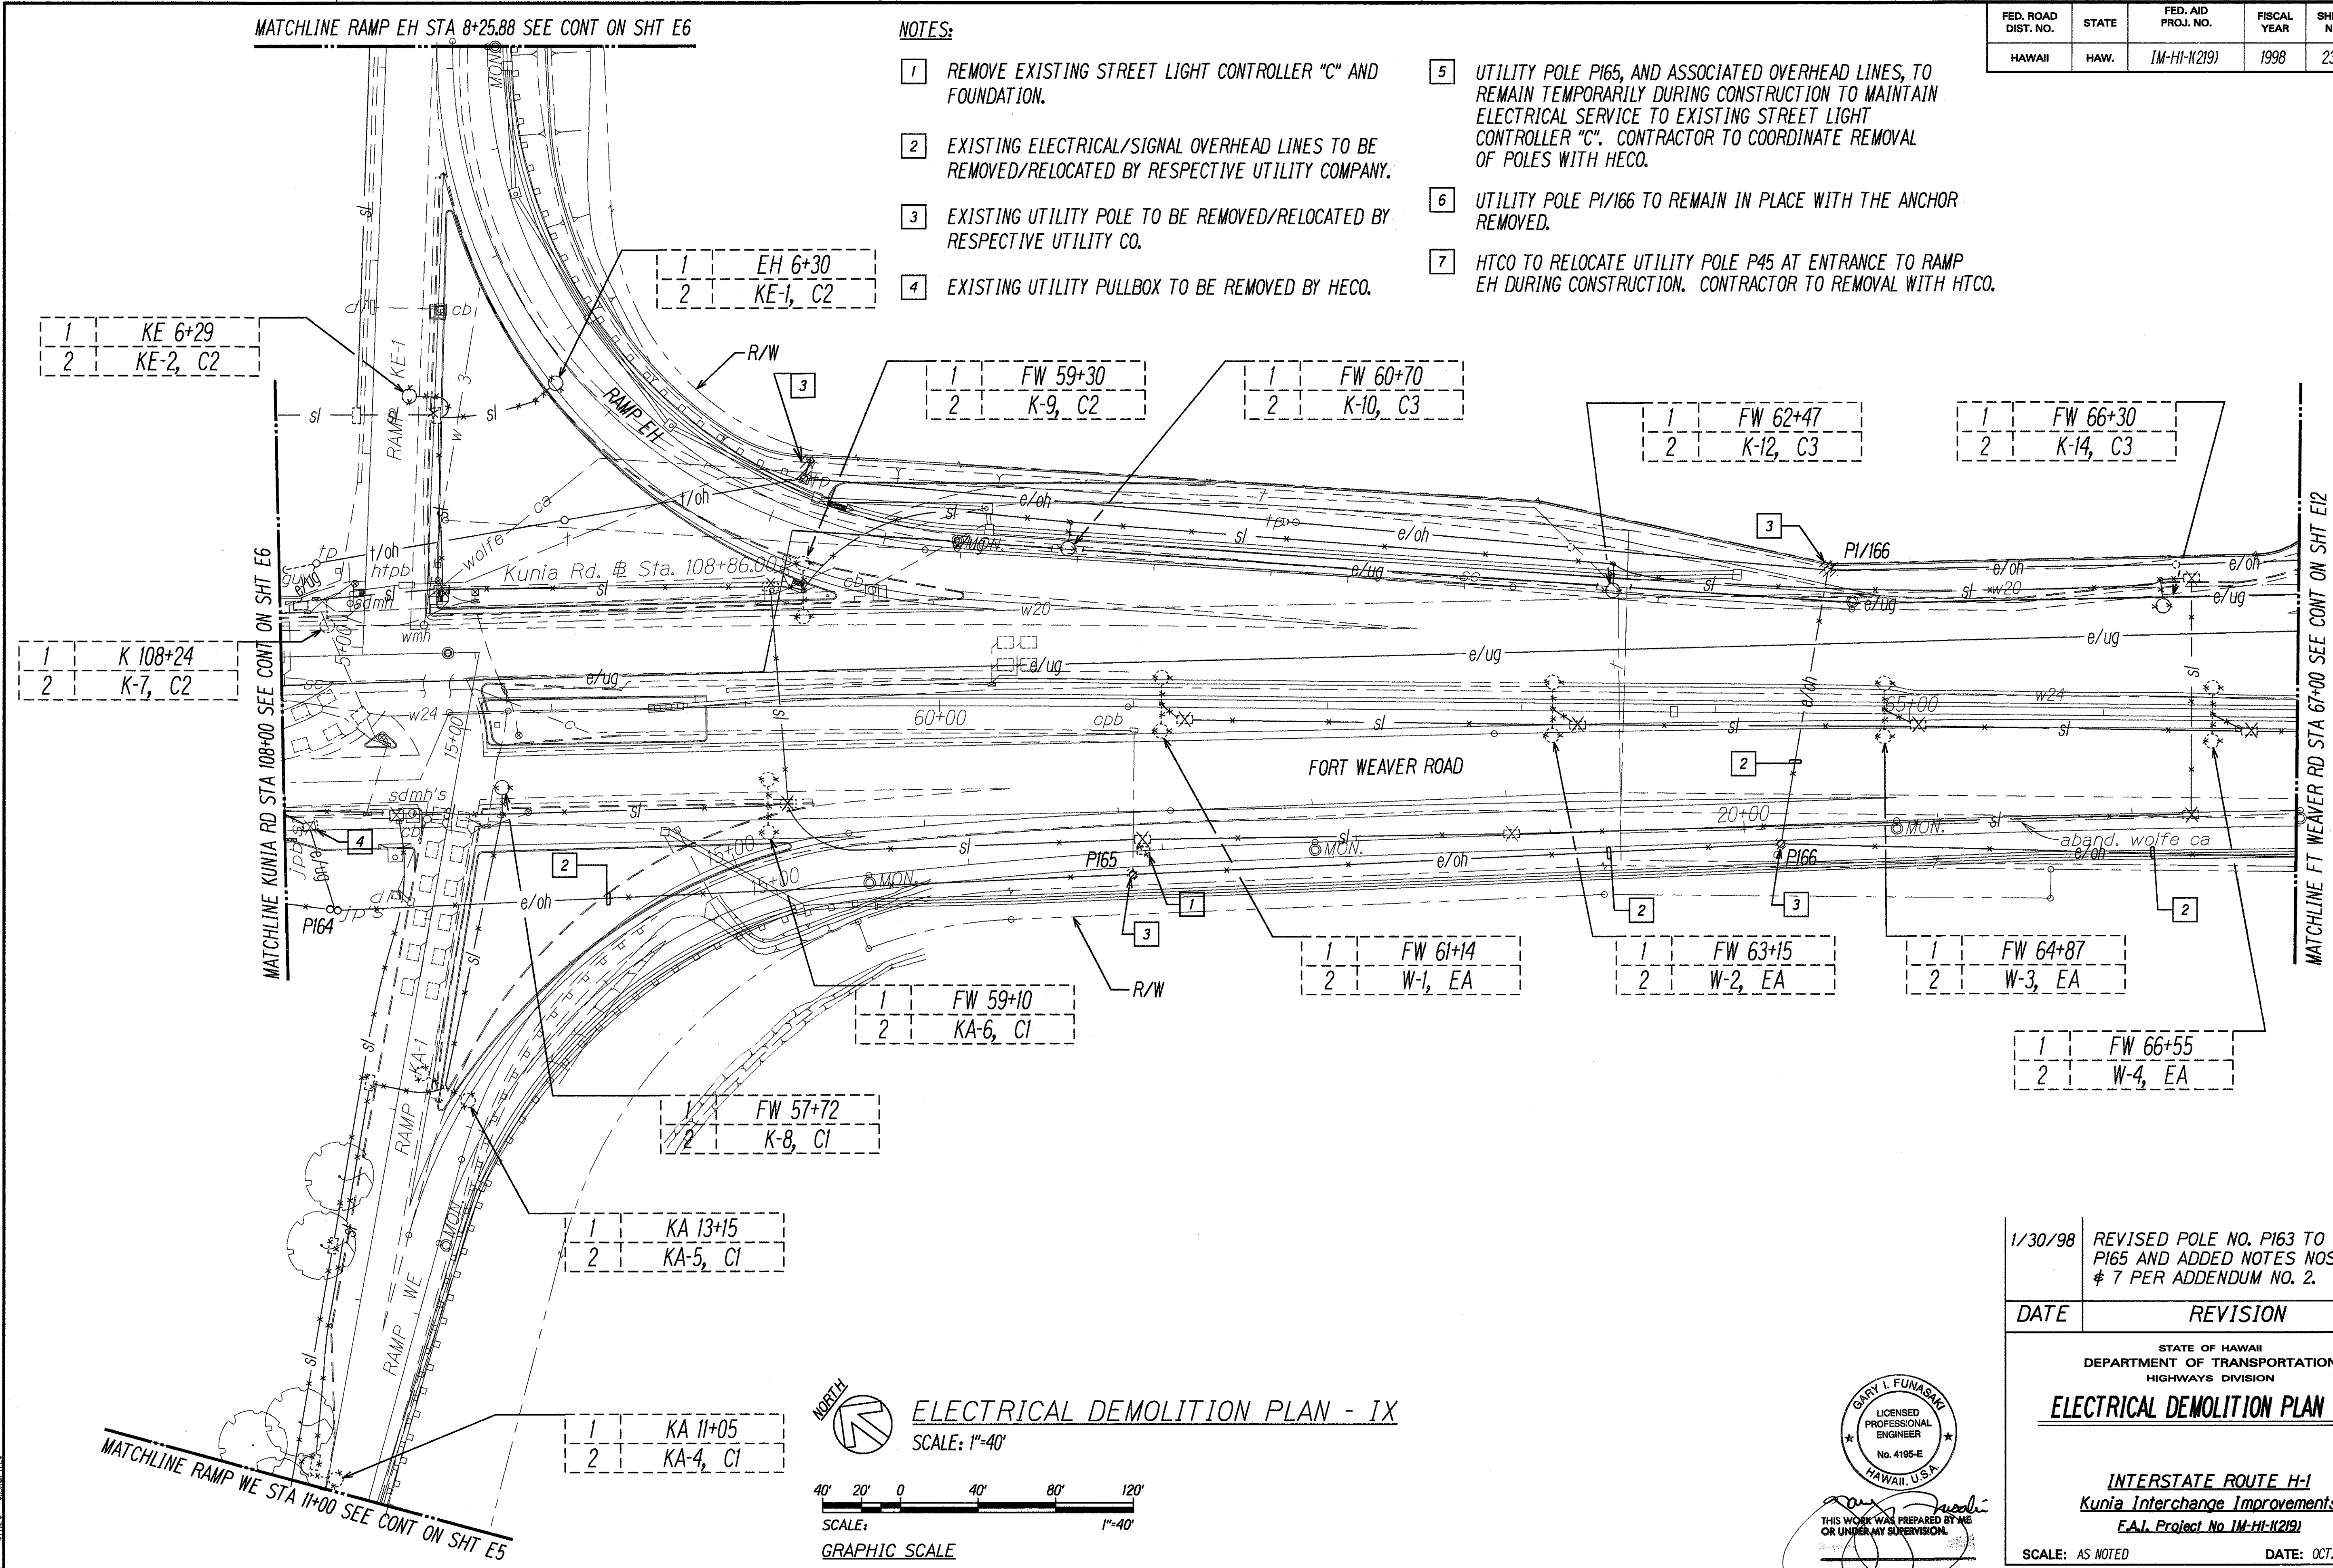

ELECTRICAL DEMOLITION PLAN - IX

SCALE: 1"=40'

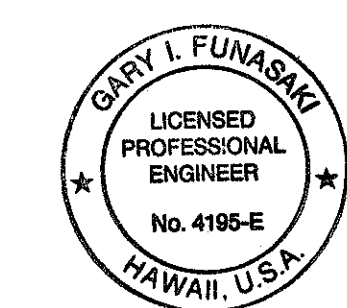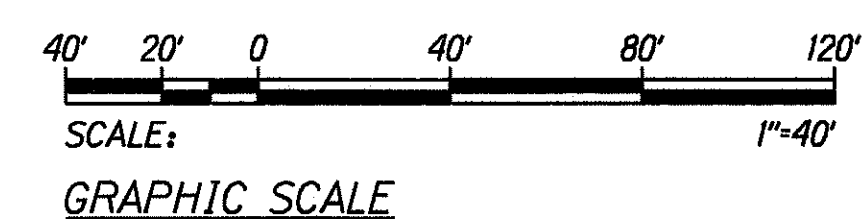


THIS WORK WAS PREPARED BY ME OR UNDER MY SUPERVISION.

1/30/98	REVISED POLE NO. PI63 TO READ PI65 AND ADDED NOTES NOS. 5, 6, & 7 PER ADDENDUM NO. 2.
DATE	REVISION
STATE OF HAWAII DEPARTMENT OF TRANSPORTATION HIGHWAYS DIVISION	
ELECTRICAL DEMOLITION PLAN - IX	
INTERSTATE ROUTE H-1 Kunia Interchange Improvements F.A.I. Project No 1M-HI-1(219)	
SCALE: AS NOTED	DATE: OCT. 1997
SHEET No. 232R OF 43 SHEETS	

SURVEY PLOTTED BY	DATE
DRAWN BY	
DESIGNED BY	
QUANTITIES BY	
CHECKED BY	
ORIGINAL PLAN	
NOTE BOOK	
NO.	

FED. ROAD DIST. NO.	STATE	FED. AID PROJ. NO.	FISCAL YEAR	SHEET NO.	TOTAL SHEETS
HAWAII	HAW.	1M-HI-1(219)	1998	234	378

- NOTES:
- 1 EXISTING UTILITY POLE TO BE REMOVED/RELOCATED BY HECO.
 - 2 EXISTING ELECTRICAL/SIGNAL OVERHEAD LINES TO BE REMOVED/RELOCATED BY RESPECTIVE UTILITY CO.
 - 3 CUT & HOT CAP EXISTING STREET LIGHT CABLES IN EXISTING PULLBOX.

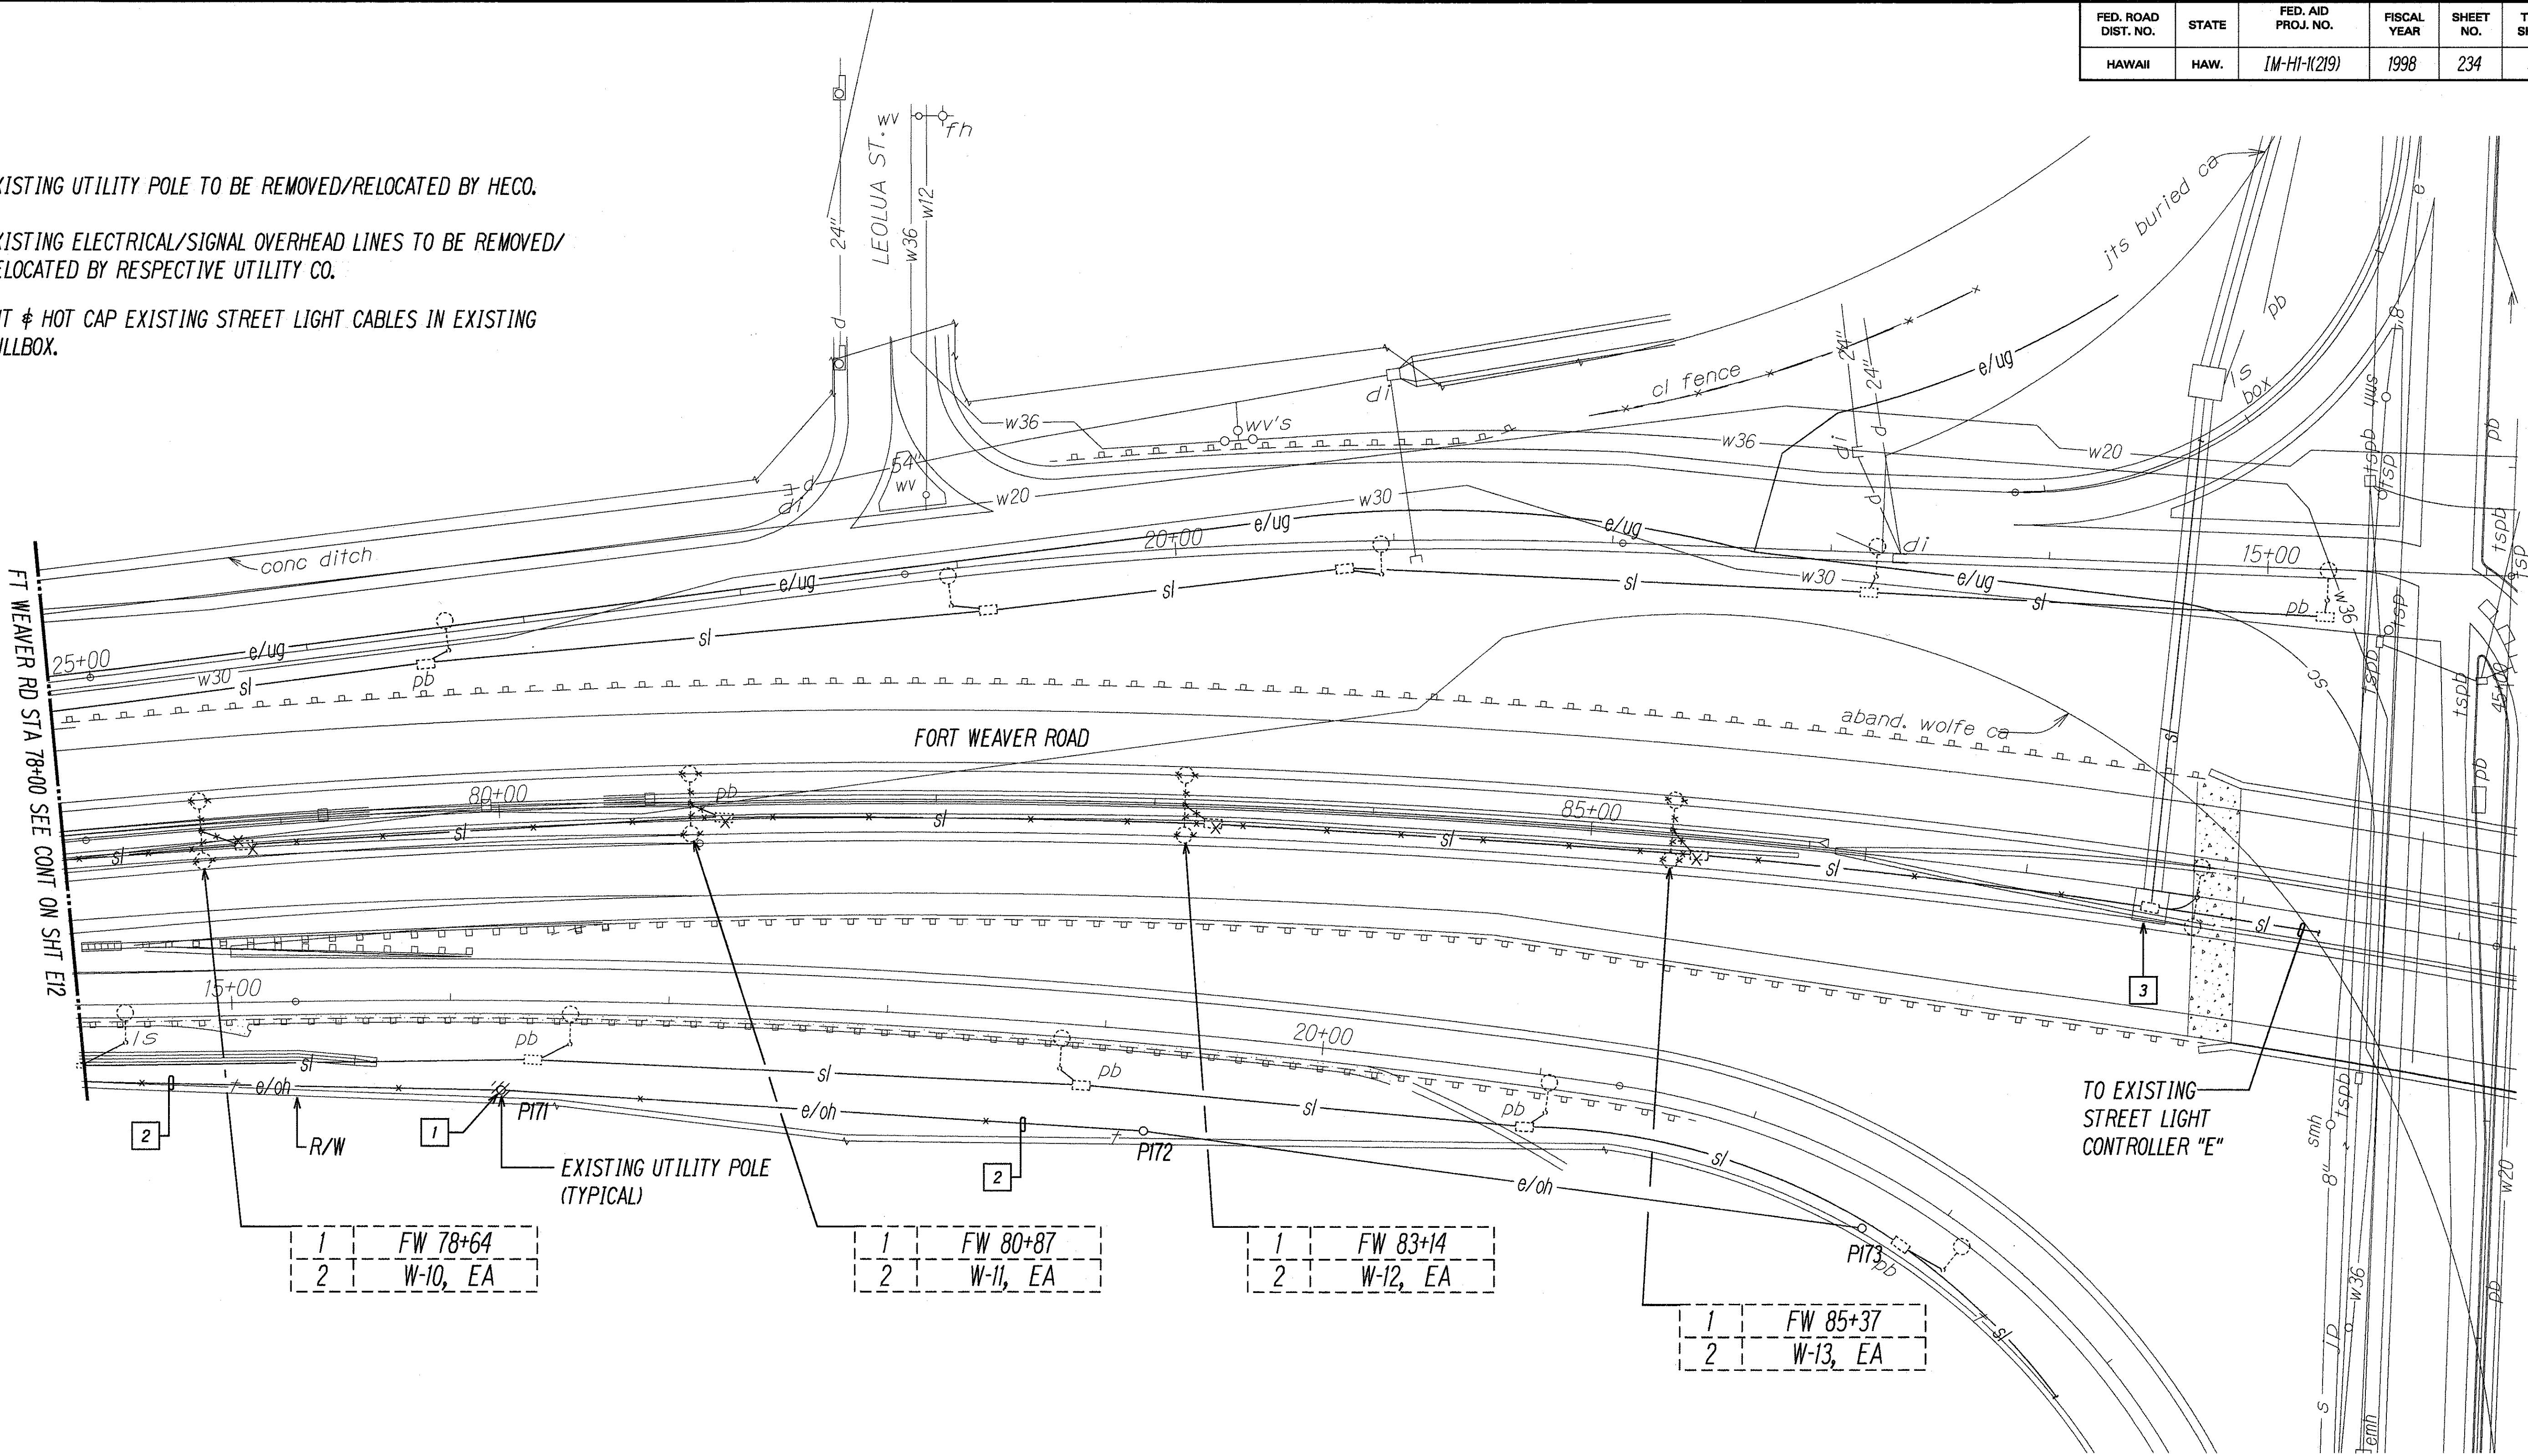

1	FW 78+64
2	W-10, EA

1	FW 80+87
2	W-11, EA

1	FW 83+14
2	W-12, EA

1	FW 85+37
2	W-13, EA


DATE	
DESIGNED BY	
DRAWN BY	
CHECKED BY	
IN CHARGE	
NOTED BY	
ORIGINAL PLAN	
NOTE BOOK	
NO.	

LAST SHEET, 8/10/79, 1/1980 BY CH. PUT TO 449
 6/24/2007 PROJECT'S 1988/1989/1991/1993/6475/64

FED. ROAD DIST. NO.	STATE	FED. AID PROJ. NO.	FISCAL YEAR	SHEET NO.	TOTAL SHEETS
HAWAII	HAW.	1M-HI-K219	1998	235	378

NOTES:

- 1
- HIGHWAY SIGN, STUB-OUT 2" C WITH PULLWIRE TO SIGN BASE LOCATION. SEE SHT T4 FOR SIGNING PLAN.
- 2
- INTERCEPT EXISTING STREET LIGHT CONDUIT WITH PULLBOX.
- 3
- SEE DETAIL 
- 4
- REPLACE EXISTING 240V BALLAST WITH 480V BALLAST. PROVIDE NEW I.D. TAG, SEE SHEET E42.
- 5
- BREAK INTO EXISTING STREET LIGHTING PULLBOX AND EXTEND 2" C, 2#8, #8 GND TO HIGHWAY SIGN PULLBOX. PROVIDE SLACK CABLE WITHIN HIGHWAY SIGN PULLBOX TO PROVIDE CONNECTION TO HIGHWAY SIGN LIGHTING. SEE SHT E33 FOR HIGHWAY SIGN LIGHTING WIRING DIAGRAM.

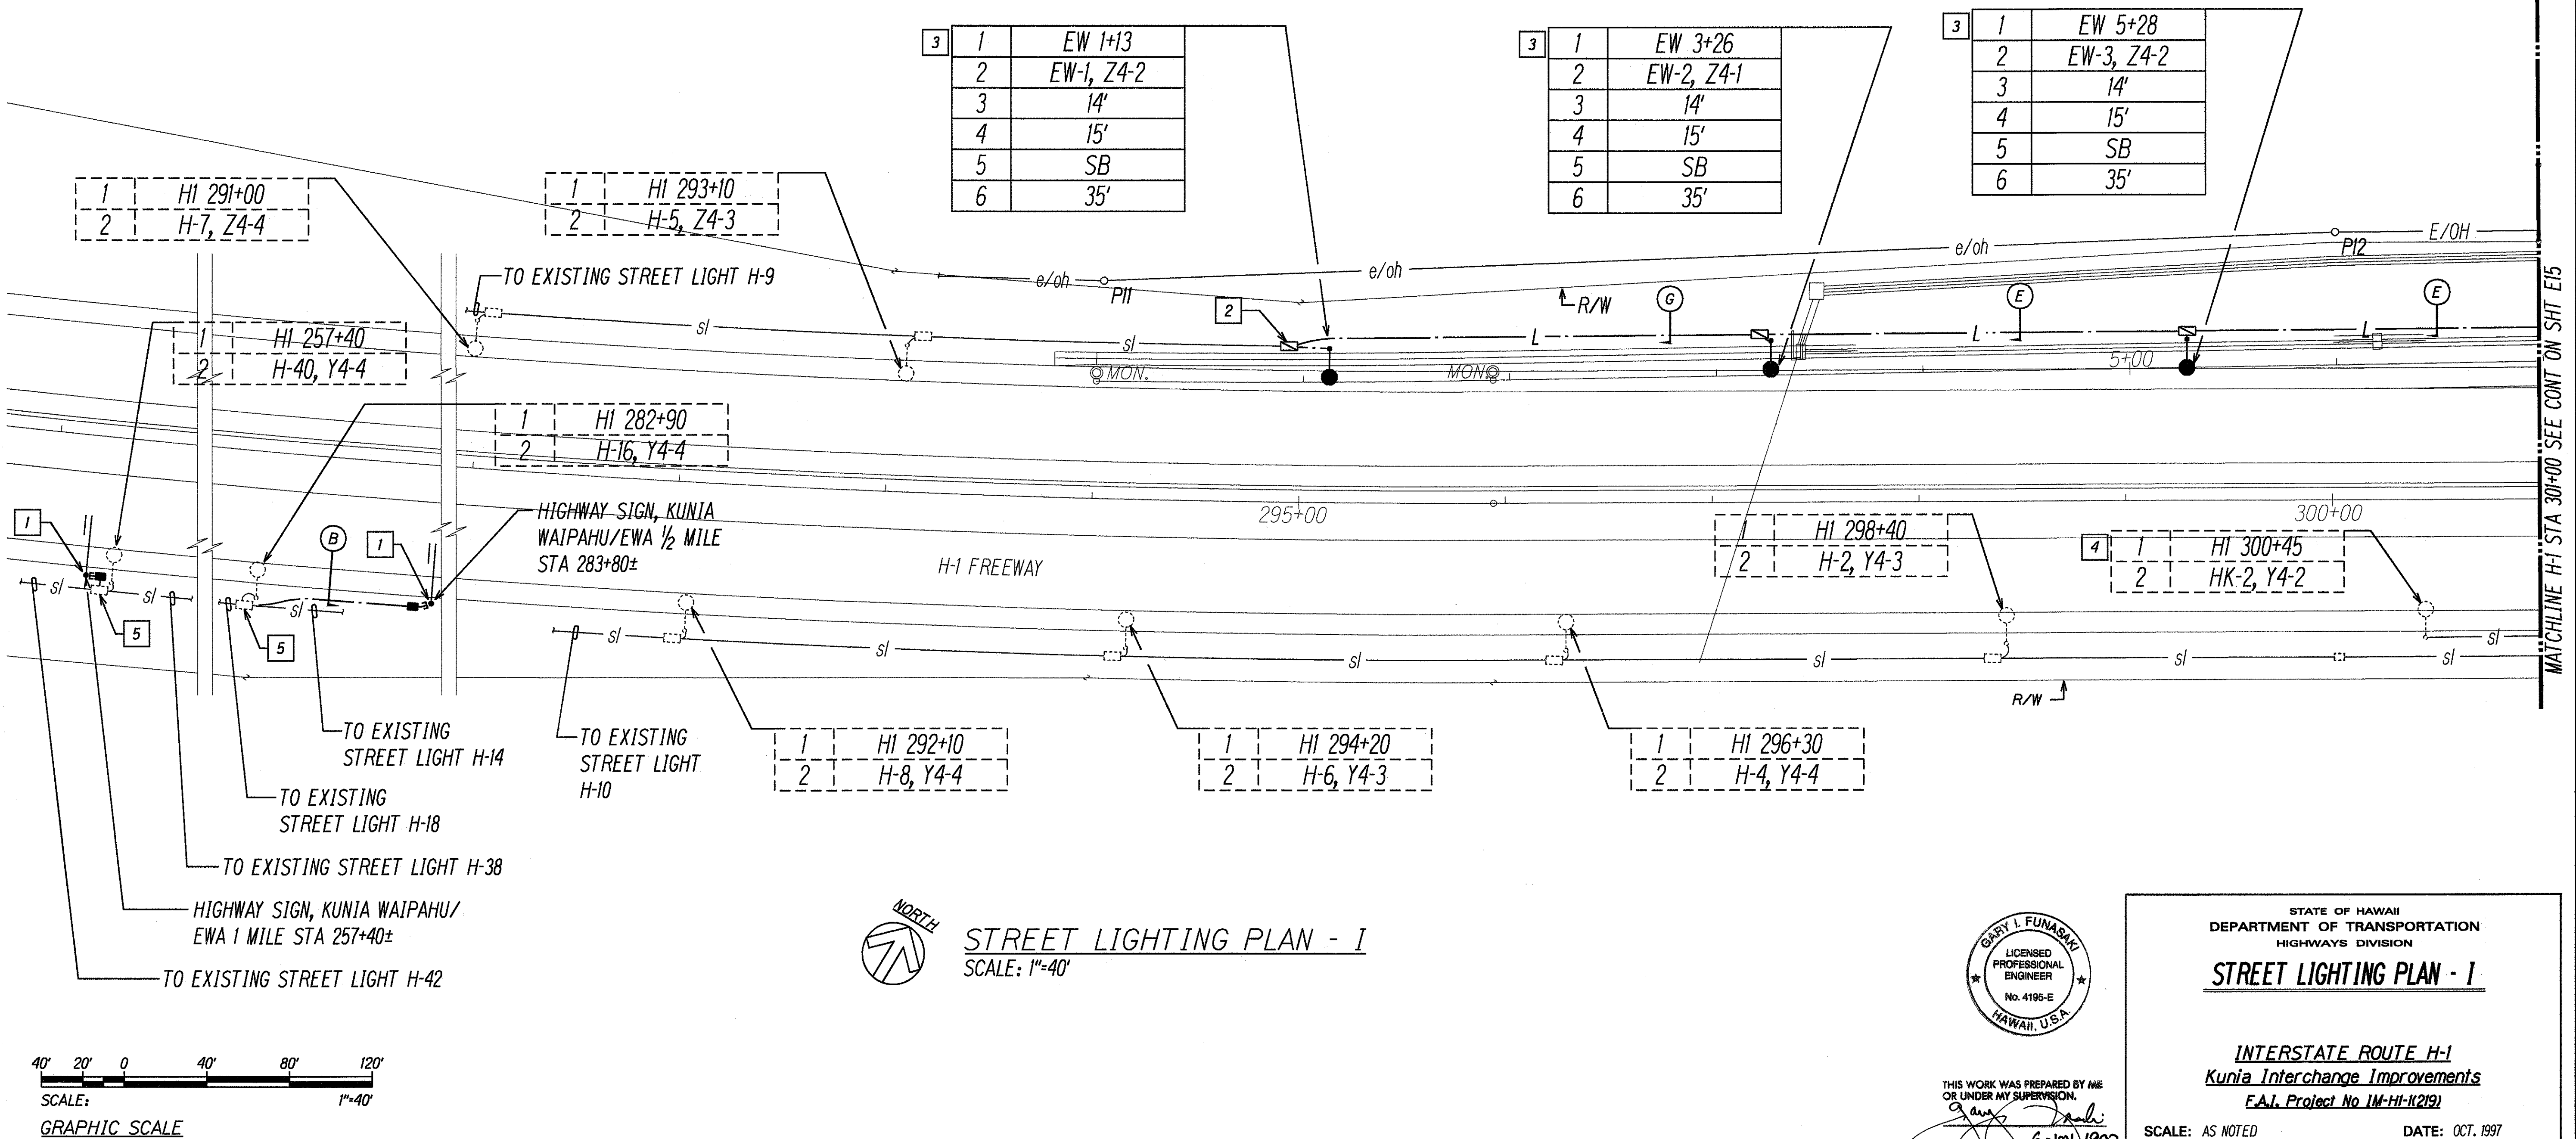

FED. ROAD DIST. NO.	STATE	FED. AID PROJ. NO.	FISCAL YEAR	SHEET NO.	TOTAL SHEETS
HAWAII	HAW.	1M-HI-1(219)	1998	236	378

NOTES:

- 1 UTILITY POLE PROVIDED BY HECO.
- 2 POWER/SIGNAL OVERHEAD LINES PROVIDED BY RESPECTIVE UTILITY CO.
- 3 HIGHWAY SIGN, STUB-OUT 2"C WITH PULLWIRE TO SIGN BASE LOCATION. SEE SHT T4 FOR SIGNING PLAN.
- 4 BREAK INTO EXISTING STREET LIGHTING PULLBOX AND EXTEND 2"C, 2*8, #8 GND TO HIGHWAY SIGN PULLBOX. PROVIDE SLACK CABLE WITHIN HIGHWAY SIGN PULLBOX TO PROVIDE CONNECTION TO HIGHWAY SIGN LIGHTING. SEE SHT E33 FOR HIGHWAY SIGN LIGHTING WIRING DIAGRAM.
- 5 UTILITY POLE PROVIDED BY HECO.


- 6 SEE DETAIL

A

E15/E26
- 7 SEE DETAIL


B

E15/E26
- 8 REPLACE EXISTING 240V BALLAST WITH 480V BALLAST. PROVIDE NEW I.D. TAG, SEE SHEET E42.

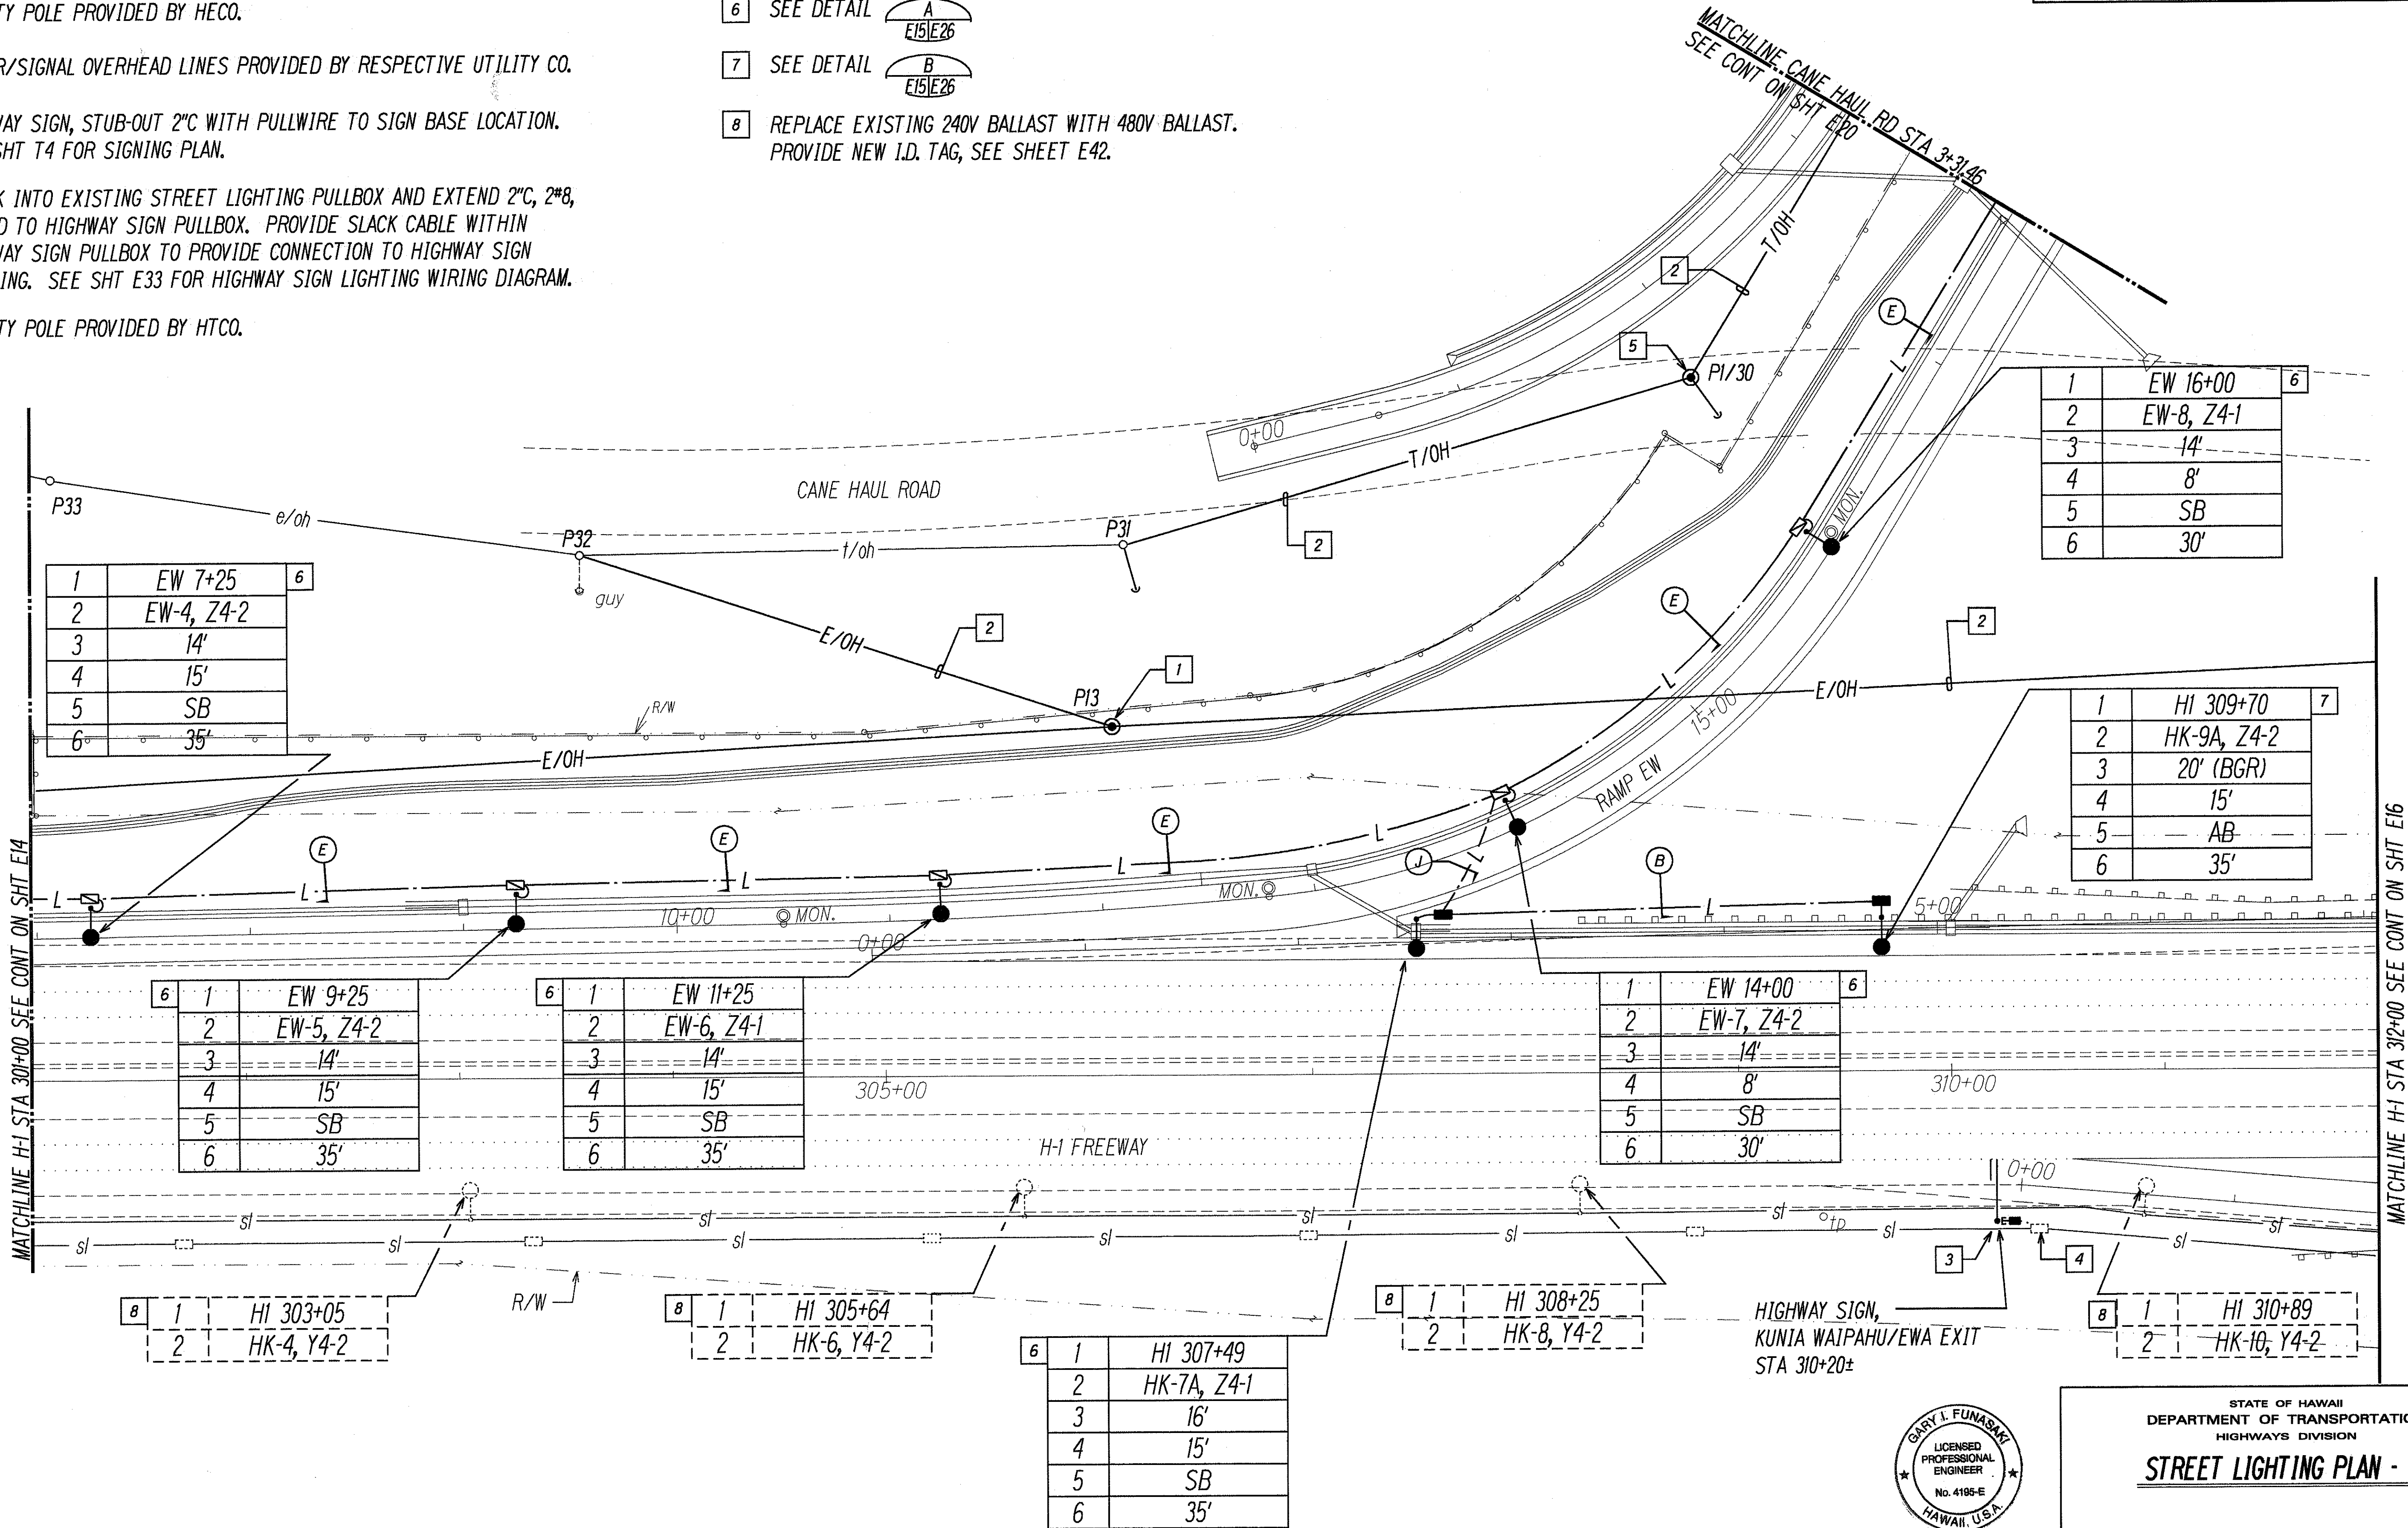


DATE	
DESIGNED BY	
DRAWN BY	
CHECKED BY	
NOTED BY	
QUANTITIES BY	
DESIGNED BY	
DRAWN BY	
CHECKED BY	
NOTED BY	
QUANTITIES BY	

LAST DATE: 10/17/97 • 11:52:39 AM • IN PLAT ST: 140
SCALE: 1"=40'

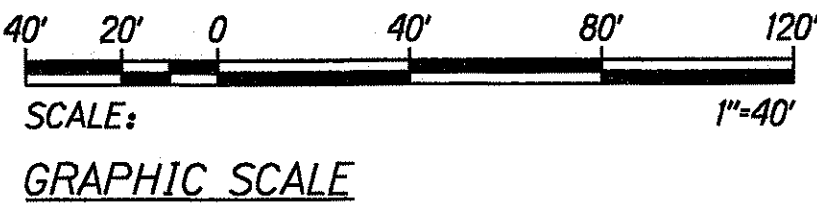

STREET LIGHTING PLAN - II
SCALE: 1"=40'

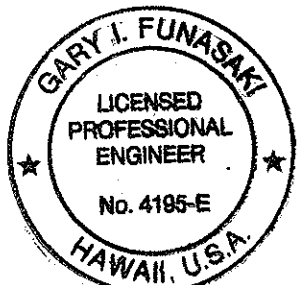

THIS WORK WAS PREPARED BY ME
OR UNDER MY SUPERVISION.
DATE: 6 NOV 1997

STATE OF HAWAII
DEPARTMENT OF TRANSPORTATION
HIGHWAYS DIVISION

STREET LIGHTING PLAN - II

INTERSTATE ROUTE H-1
Kunia Interchange Improvements
F.A.I. Project No. 1M-HI-1(219)

SCALE: AS NOTED DATE: OCT. 1997

SHEET No. E15 OF 43 SHEETS

FED. ROAD DIST. NO.	STATE	FED. AID PROJ. NO.	FISCAL YEAR	SHEET NO.	TOTAL SHEETS
HAWAII	HAW.	1M-HI-K(219)	1998	237	378

MATCHLINE RAMP HE STA 21+00
SEE CONT ON SHT E20

1	HE 21+79	5
2	HE-10, Z4-5	
3	14'	
4	8'	
5	SB	
6	30'	

NOTES:

- UTILITY POLE PROVIDED BY HECO.
- POWER/SIGNAL OVERHEAD LINES PROVIDED BY RESPECTIVE UTILITY CO.
- INTERCEPT EXISTING DIRECT BURIED CABLE WITH PULLBOX.
- BREAK INTO EXISTING HANDHOLE.

- SEE DETAIL A E16E26
- SEE DETAIL B E16E26
- REPLACE EXISTING 240V BALLAST WITH 480V BALLAST. PROVIDE NEW I.D. TAG, SEE SHEET E42.

- COUPLE TO EXISTING CONDUIT. PROVIDE NEW CABLE AS REQUIRED.

1	HE 23+17	5
2	HE-11, Z4-6	
3	14'	
4	8'	
5	SB	
6	30'	

1	HE 25+66	5
2	HE-12, Z4-5	
3	14'	
4	8'	
5	SB	
6	30'	

1	HE 27+74	5
2	HE-13, Z4-6	
3	14'	
4	8'	
5	SB	
6	30'	

1	HE 29+46	5
2	HE-14, Z4-5	
3	14'	
4	15'	
5	SB	
6	35'	

1	HE 31+06	6
2	HE-15, Z4-6	
3	18' (BGR)	
4	15'	
5	AB	
6	35'	

1	HE 33+19	6
2	HE-16, Z4-5	
3	18' (BGR)	
4	15'	
5	AB	
6	35'	

1	HI 314+71	5
2	HK-13A, Z4-6	
3	18'	
4	15'	
5	SB	
6	35'	

1	HI 312+20	6
2	HK-11A, Z4-5	
3	19' (BGR)	
4	15'	
5	AB	
6	35'	

1	HI 317+44	5
2	HK-15A, Z4-5	
3	16'	
4	15'	
5	SB	
6	35'	

1	KA 6+65	7
2	KA-2, Y4-2	

1	KA 4+66	6
2	KA-1A, Y4-2	
3	10' (BGR)	
4	8'	
5	AB	
6	30'	

1	HI 316+04	7
2	HK-14, Y4-2	

1	HI 318+65	7
2	HK-16, Y4-2	

1	HI 321+25	7
2	HK-18, Y4-2	


1	HI 313+45	7
2	HK-12, Y4-2	



SCALE:
GRAPHIC SCALE



STREET LIGHTING PLAN - III
SCALE: 1"=40'

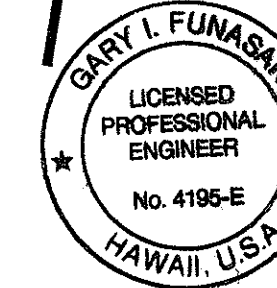

THIS WORK WAS PREPARED BY ME OR UNDER MY SUPERVISION.

DATE: OCT. 1997

STATE OF HAWAII
DEPARTMENT OF TRANSPORTATION
HIGHWAYS DIVISION

STREET LIGHTING PLAN - III

INTERSTATE ROUTE H-1
Kunia Interchange Improvements
F.A.I. Project No. 1M-HI-K(219)

SCALE: AS NOTED
SHEET No. E16 OF 43 SHEETS

FED. ROAD DIST. NO.	STATE	FED. AID PROJ. NO.	FISCAL YEAR	SHEET NO.	TOTAL SHEETS
HAWAII	HAW.	IM-H1-1(219)	1998	238	378


NOTES:

- UTILITY POLE PROVIDED BY HECO.
- POWER/SIGNAL OVERHEAD LINES PROVIDED BY RESPECTIVE UTILITY CO.
- HECO 12KV MID-SPAN TAP TO ARMY BUNKER SERVICE.
- SEE DETAIL 

- INTERCEPT EXISTING DIRECT BURIED CABLE WITH PULLBOX.
- HIGHWAY SIGN, STUB-OUT 2" C WITH PULLWIRE TO SIGN BASE LOCATION. SEE SHT T6 FOR SIGNING PLAN.
- PROVIDE SLACK CABLE WITHIN HIGHWAY SIGN PULLBOX TO PROVIDE CONNECTION TO HIGHWAY SIGN LIGHTING.
- HECO 5' X 7' PULLBOX, VERIFY EXACT LOCATION IN THE FIELD.
- CABLES REMOVED BY HECO, ABANDON DUCTLINE IN PLACE.
- REPLACE EXISTING 240V BALLAST WITH 480V BALLAST. PROVIDE NEW I.D. TAG, SEE SHEET E42.

- SEE DETAIL 
- HECO TO PROVIDE CONDUIT OPENINGS INTO PULLBOX. EXTEND CONDUITS TO PULLBOX AND REPAIR PULLBOX TO MATCH EXISTING CONDITION. COORDINATE LOCATION OF CONDUIT ENTRY INTO PULLBOX WITH HECO.
- DUCTLINE TO CROSS UNDER 24" CULVERT.
- SEE  FOR TYPICAL DUCT SECTION BEHIND RETAINING WALL.

1	HE 0+65
2	HE-1, Z4-6
3	14'
4	8'
5	SB
6	30'

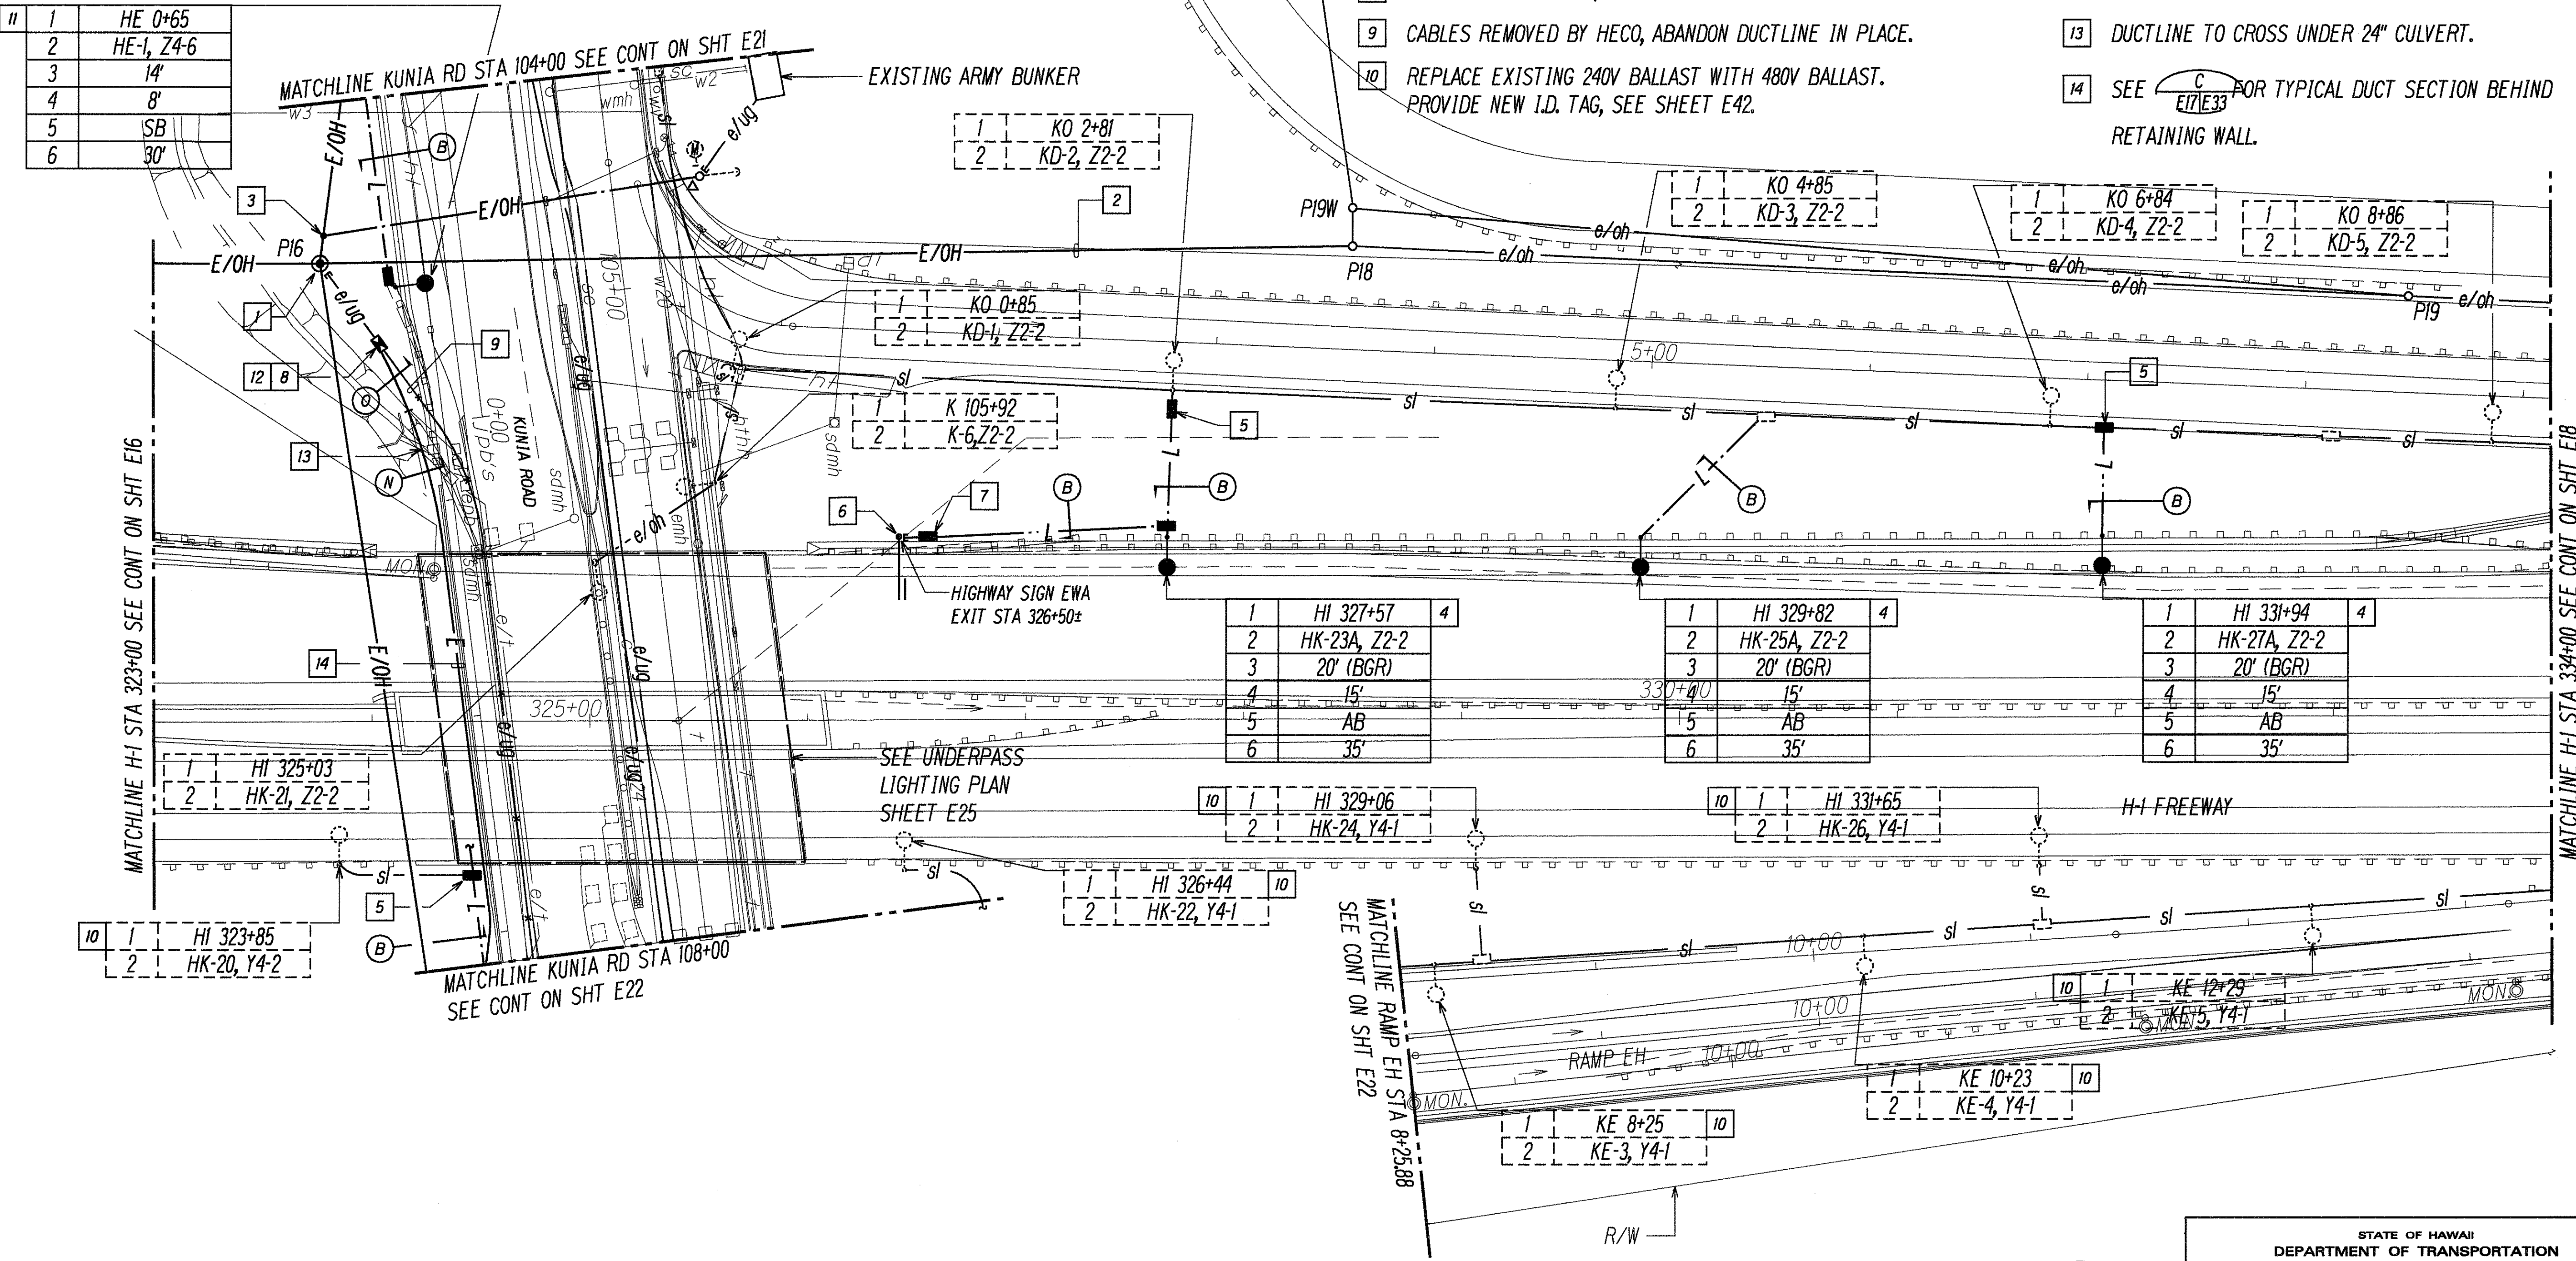

1	HI 325+03
2	HK-21, Z2-2

1	HI 323+85
2	HK-20, Y4-2

1	KO 2+81
2	KD-2, Z2-2

1	K 105+92
2	K-6, Z2-2

1	HI 327+57
2	HK-23A, Z2-2
3	20' (BGR)
4	15'
5	AB
6	35'

1	HI 329+82
2	HK-25A, Z2-2
3	20' (BGR)
4	15'
5	AB
6	35'

1	HI 331+94
2	HK-27A, Z2-2
3	20' (BGR)
4	15'
5	AB
6	35'

1	HI 329+06
2	HK-24, Y4-1

1	HI 326+44
2	HK-22, Y4-1


1	HI 331+65
2	HK-26, Y4-1

1	KE 12+29
2	KE-5, Y4-1

1	KE 8+25
2	KE-3, Y4-1

1	KE 10+23
2	KE-4, Y4-1


DATE	
SURVEY PLOTTED BY	
ORIGINAL PLAN	
DESIGNED BY	
CHECKED BY	
NOTES	
LAST DATE, OURS	
DATE	
BY	

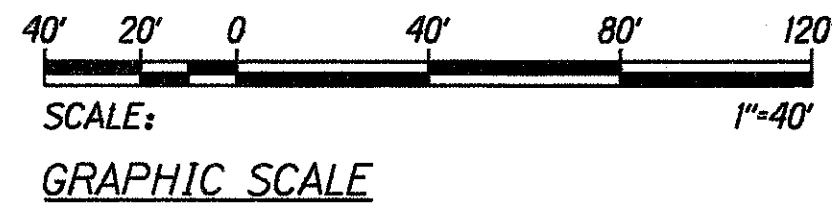

STREET LIGHTING PLAN - IV
SCALE: 1"=40'

4/9/99 RELOCATED UNDERGROUND ELECTRICAL LINES BETWEEN KUNIA ROAD BL STA. 104+40± AND STA. 108+20± RT. REVISED NOTES 8 & 9 AND ADDED NOTES 12, 13 & 14

DATE REVISION

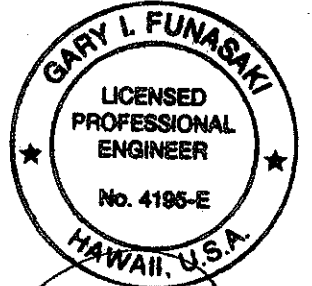


THIS WORK WAS PREPARED BY ME OR UNDER MY SUPERVISION.

STATE OF HAWAII
DEPARTMENT OF TRANSPORTATION
HIGHWAYS DIVISION
STREET LIGHTING PLAN - IV

INTERSTATE ROUTE H-1
Kunia Interchange Improvements
F.A.I. Project No. IM-H1-1(219)

SCALE: AS NOTED DATE: OCT. 1997
SHEET No. E17 OF 43 SHEETS

FED. ROAD DIST. NO.	STATE	FED. AID PROJ. NO.	FISCAL YEAR	SHEET NO.	TOTAL SHEETS
HAWAII	HAW.	1M-HI-1(219)	1998	239	378


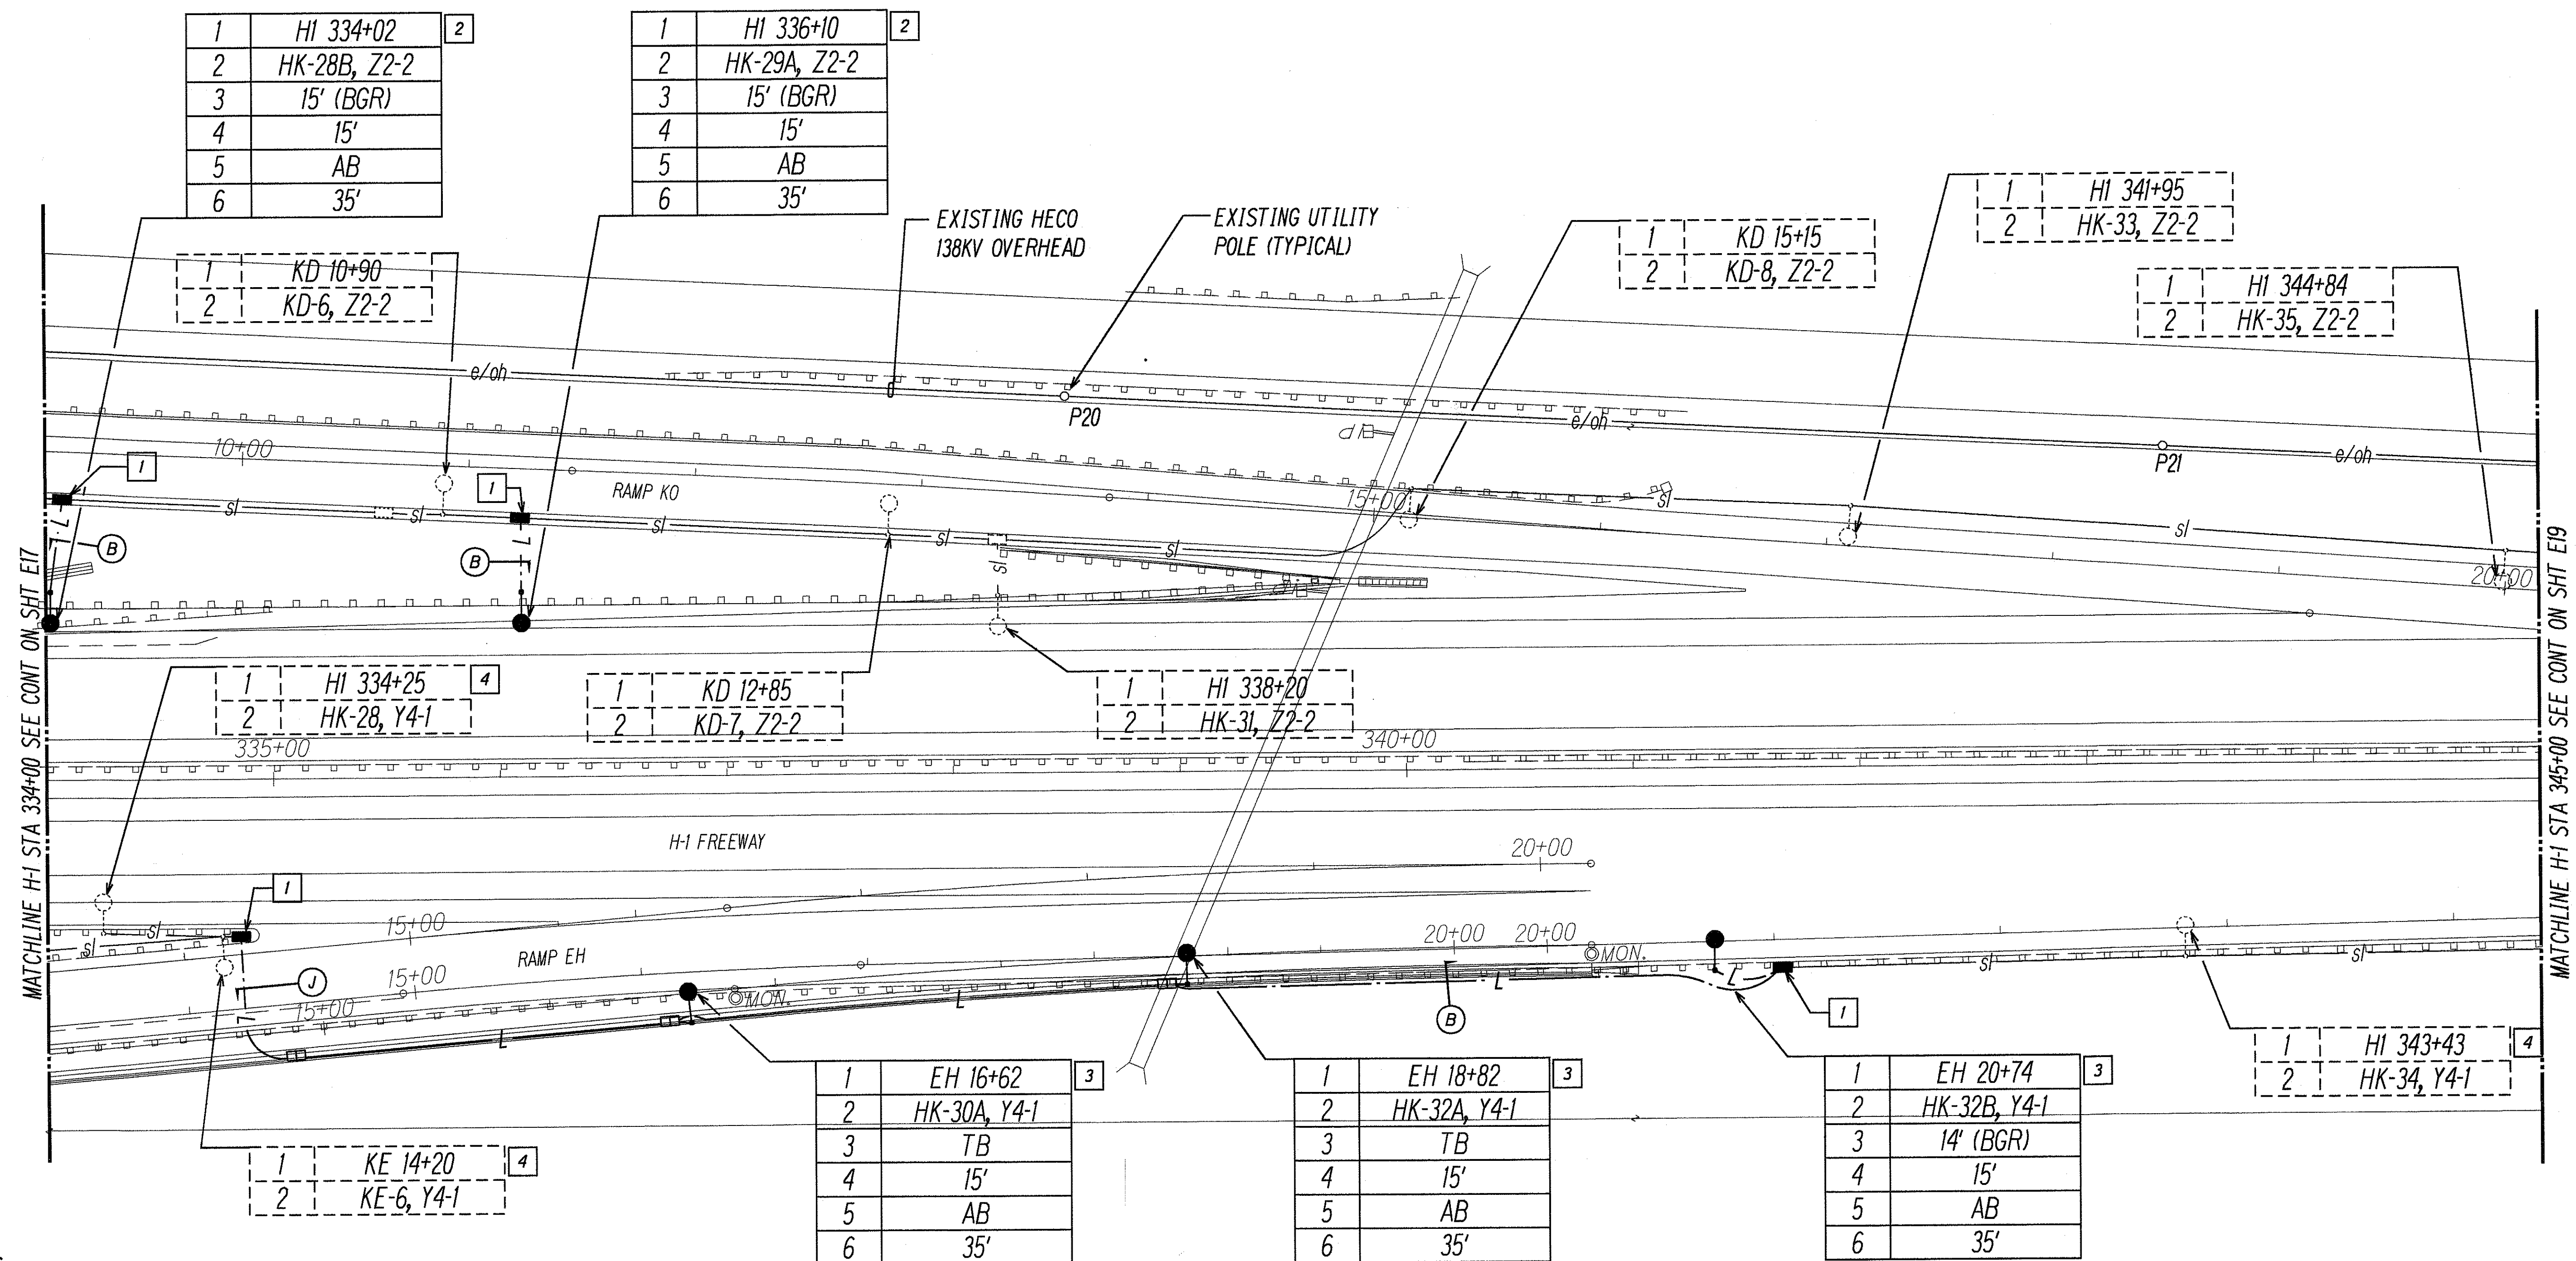


NOTES:

- 1 INTERCEPT EXISTING DIRECT BURIED CABLE WITH HANDHOLE.
- 2 SEE DETAIL  B
E18/E26
- 3 SEE DETAIL  C
E18/E26
- 4 REPLACE EXISTING 240V BALLAST WITH 480V BALLAST. PROVIDE NEW I.D. TAG, SEE SHEET E42.



STREET LIGHTING PLAN - V
SCALE: 1"=40'

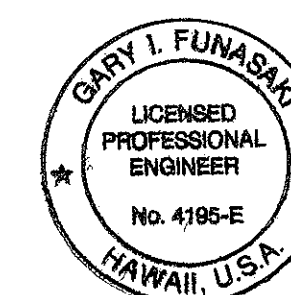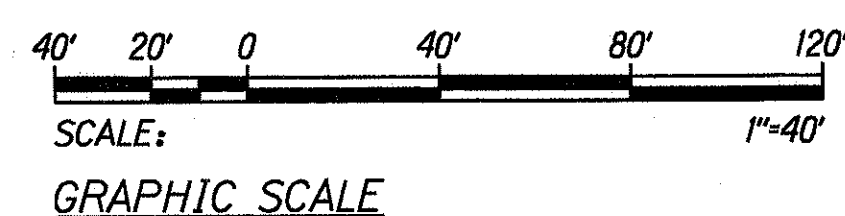

THIS WORK WAS PREPARED BY ME
OR UNDER MY SUPERVISION
[Signature]
6 NOV 1997

STATE OF HAWAII
DEPARTMENT OF TRANSPORTATION
HIGHWAYS DIVISION


STREET LIGHTING PLAN - V

INTERSTATE ROUTE H-1
Kunia Interchange Improvements
F.A.I. Project No 1M-HI-1(219)

SCALE: AS NOTED DATE: OCT. 1997

SHEET No. E18 OF 43 SHEETS

FED. ROAD DIST. NO.	STATE	FED. AID PROJ. NO.	FISCAL YEAR	SHEET NO.	TOTAL SHEETS
HAWAII	HAW.	1M-HI-1(219)	1998	241	378

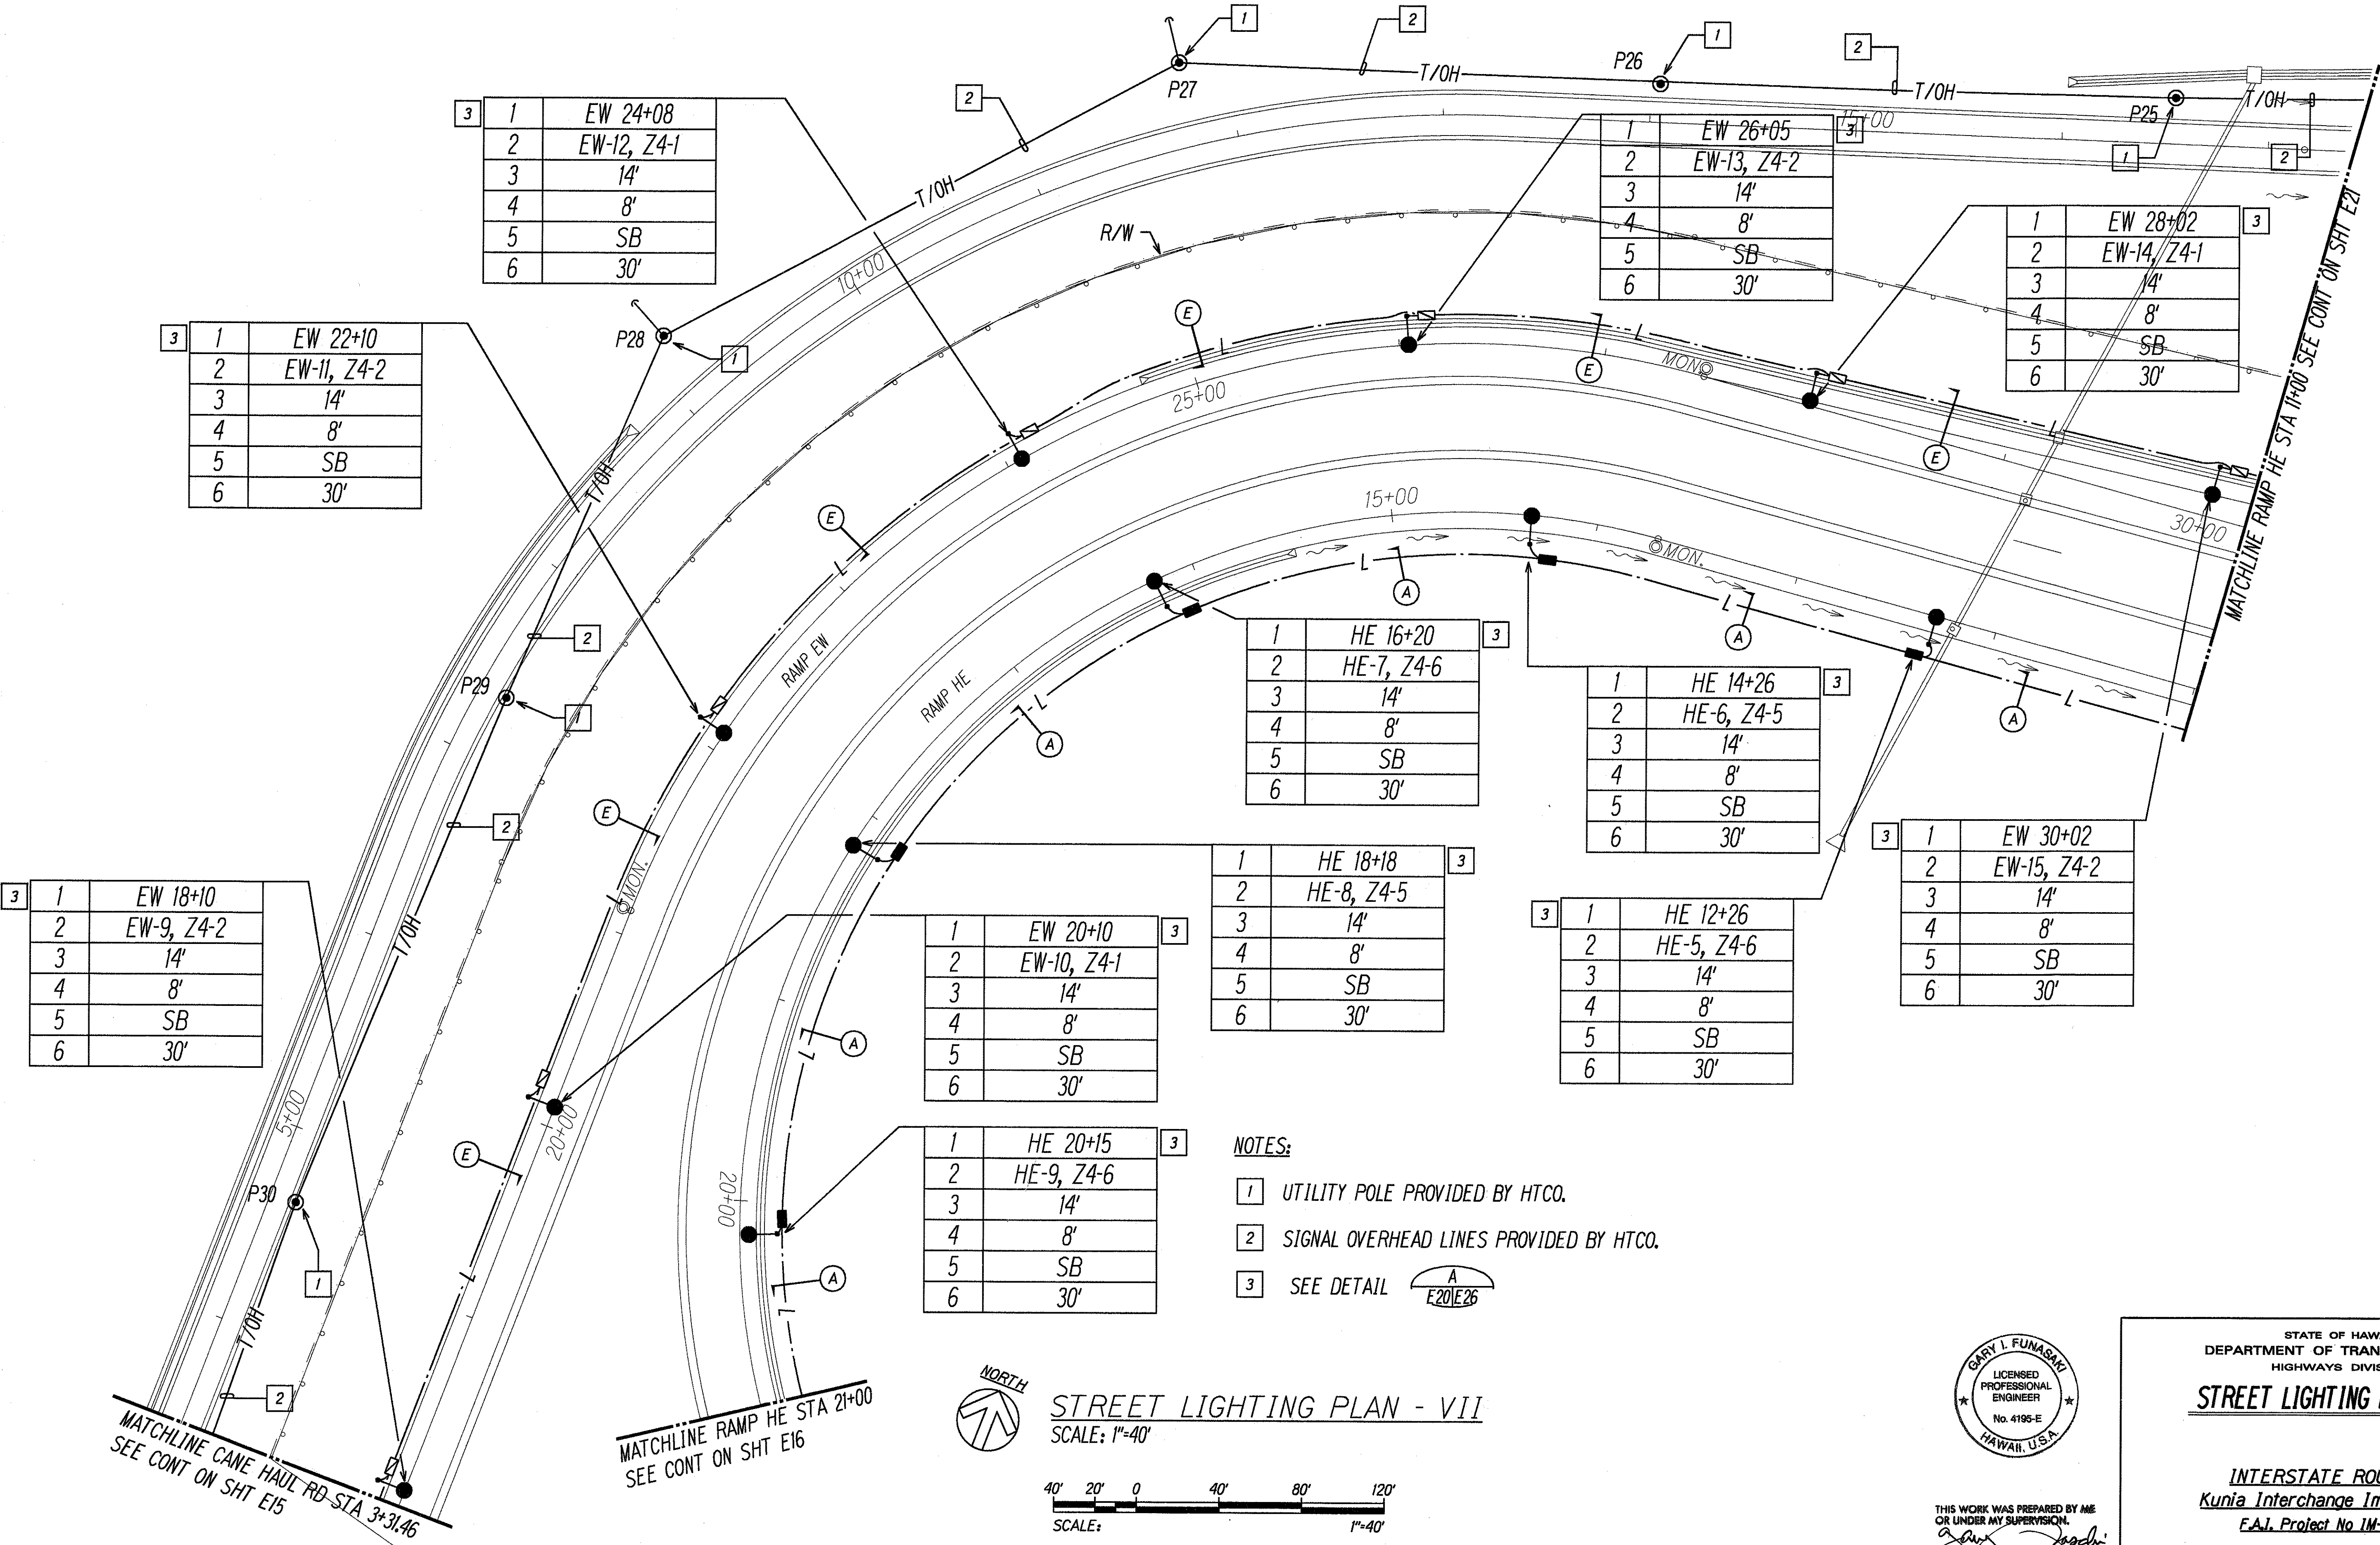

1	EW 24+08
2	EW-12, Z4-1
3	14'
4	8'
5	SB
6	30'

1	EW 22+10
2	EW-11, Z4-2
3	14'
4	8'
5	SB
6	30'

1	EW 26+05
2	EW-13, Z4-2
3	14'
4	8'
5	SB
6	30'

1	EW 28+02
2	EW-14, Z4-1
3	14'
4	8'
5	SB
6	30'

1	EW 18+10
2	EW-9, Z4-2
3	14'
4	8'
5	SB
6	30'

1	HE 16+20
2	HE-7, Z4-6
3	14'
4	8'
5	SB
6	30'

1	HE 14+26
2	HE-6, Z4-5
3	14'
4	8'
5	SB
6	30'

1	EW 30+02
2	EW-15, Z4-2
3	14'
4	8'
5	SB
6	30'

1	HE 18+18
2	HE-8, Z4-5
3	14'
4	8'
5	SB
6	30'

1	HE 12+26
2	HE-5, Z4-6
3	14'
4	8'
5	SB
6	30'



1	EW 20+10
2	EW-10, Z4-1
3	14'
4	8'
5	SB
6	30'

1	HE 20+15
2	HE-9, Z4-6
3	14'
4	8'
5	SB
6	30'

- NOTES:
- 1 UTILITY POLE PROVIDED BY HTCO.
 - 2 SIGNAL OVERHEAD LINES PROVIDED BY HTCO.
 - 3 SEE DETAIL



STREET LIGHTING PLAN - VII
SCALE: 1"=40'

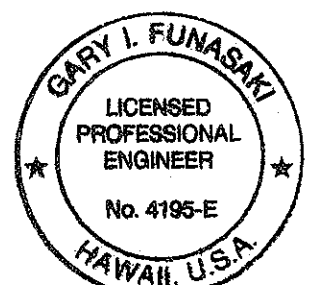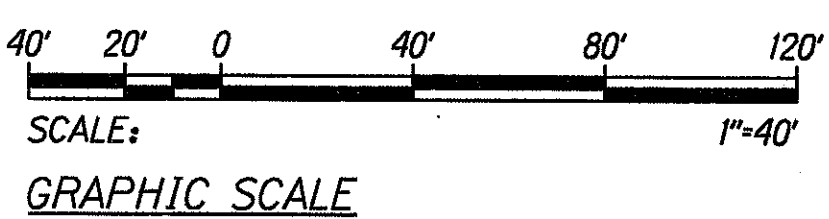

STATE OF HAWAII
DEPARTMENT OF TRANSPORTATION
HIGHWAYS DIVISION

STREET LIGHTING PLAN - VII


INTERSTATE ROUTE H-1
Kunia Interchange Improvements
F.A.I. Project No. 1M-HI-1(219)

SCALE: AS NOTED DATE: OCT. 1997
SHEET No. E20 OF 43 SHEETS

DATE	
DESIGNED BY	
CHECKED BY	
IN CHARGE	
NOTED	
ORIGINAL PLAN	
TRACED BY	
DESIGNED BY	
CHECKED BY	
IN CHARGE	
NOTED	
ORIGINAL PLAN	

LAST DATE: 10/1/97
DRAWN BY: G. L. FUNASAKA
CHECKED BY: G. L. FUNASAKA
IN CHARGE: G. L. FUNASAKA
NOTED: G. L. FUNASAKA
ORIGINAL PLAN: G. L. FUNASAKA
TRACED BY: G. L. FUNASAKA
DESIGNED BY: G. L. FUNASAKA
CHECKED BY: G. L. FUNASAKA
IN CHARGE: G. L. FUNASAKA
NOTED: G. L. FUNASAKA
ORIGINAL PLAN: G. L. FUNASAKA

FED. ROAD DIST. NO.	STATE	FED. AID PROJ. NO.	FISCAL YEAR	SHEET NO.	TOTAL SHEETS
HAWAII	HAW.	1M-HI-K219	1998	242	378

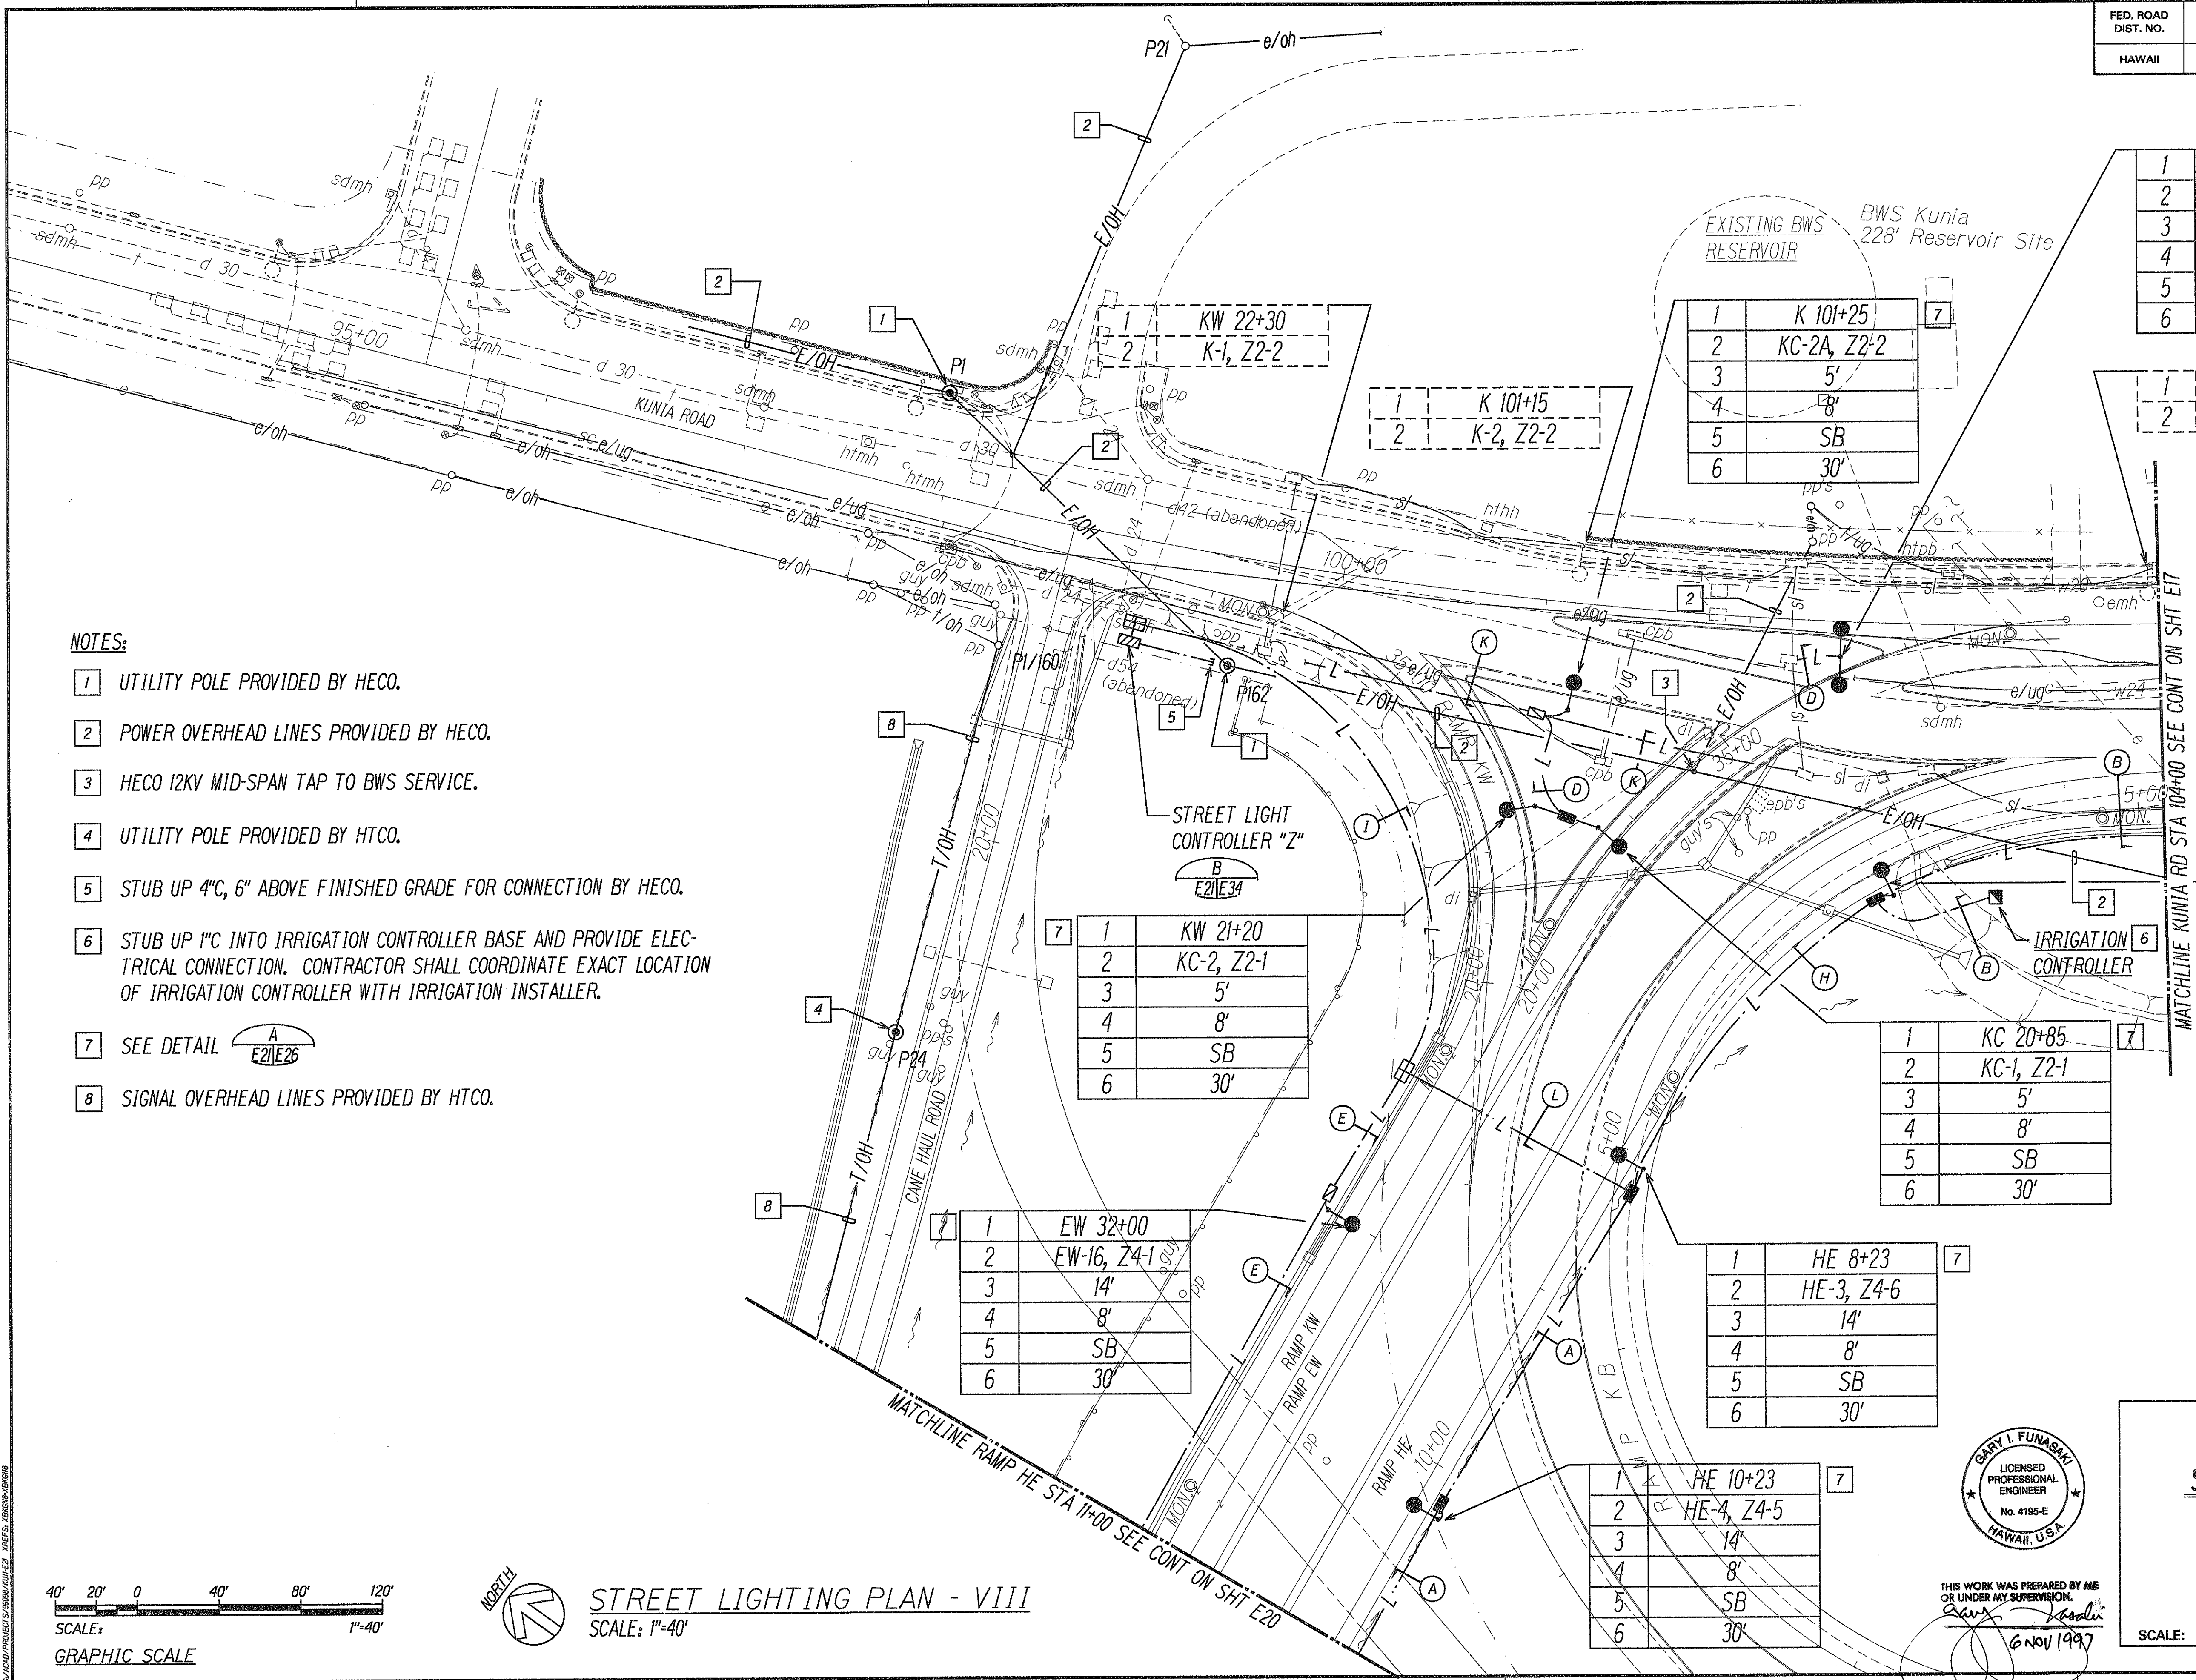

- NOTES:
- 1 UTILITY POLE PROVIDED BY HECO.
 - 2 POWER OVERHEAD LINES PROVIDED BY HECO.
 - 3 HECO 12KV MID-SPAN TAP TO BWS SERVICE.
 - 4 UTILITY POLE PROVIDED BY HECO.
 - 5 STUB UP 4"C, 6" ABOVE FINISHED GRADE FOR CONNECTION BY HECO.
 - 6 STUB UP 1"C INTO IRRIGATION CONTROLLER BASE AND PROVIDE ELECTRICAL CONNECTION. CONTRACTOR SHALL COORDINATE EXACT LOCATION OF IRRIGATION CONTROLLER WITH IRRIGATION INSTALLER.
 - 7 SEE DETAIL A E21E26
 - 8 SIGNAL OVERHEAD LINES PROVIDED BY HECO.

1	K 102+45	7
2	K-3, Z2-2	
3	5'	
4	8'	
5	SB	
6	30'	

1	K 103+95	
2	K-4, Z2-2	

1	K 101+25	7
2	KC-2A, Z2-2	
3	5'	
4	8'	
5	SB	
6	30'	

1	K 101+15	
2	K-2, Z2-2	

1	KW 21+20	7
2	KC-2, Z2-1	
3	5'	
4	8'	
5	SB	
6	30'	

1	EW 32+00	
2	EW-16, Z4-1	
3	14'	
4	8'	
5	SB	
6	30'	

1	KC 20+85	7
2	KC-1, Z2-1	
3	5'	
4	8'	
5	SB	
6	30'	

1	HE 6+29	7
2	HE-2, Z4-5	
3	14'	
4	8'	
5	SB	
6	30'	

1	HE 8+23	7
2	HE-3, Z4-6	
3	14'	
4	8'	
5	SB	
6	30'	

1	HE 10+23	7
2	HE-4, Z4-5	
3	14'	
4	8'	
5	SB	
6	30'	



THIS WORK WAS PREPARED BY ME OR UNDER MY SUPERVISION.
 6 NOV 1997

STATE OF HAWAII
DEPARTMENT OF TRANSPORTATION
HIGHWAYS DIVISION



STREET LIGHTING PLAN - VIII

INTERSTATE ROUTE H-1
Kunia Interchange Improvements
F.A.I. Project No. 1M-HI-K219

SCALE: AS NOTED
SHEET No. E21 OF 43 SHEETS


DATE: OCT. 1997

SURVEY PLOTTED BY	DATE
DRAWN BY	
CHECKED BY	
NOTE BOOK	
CHECKED BY	

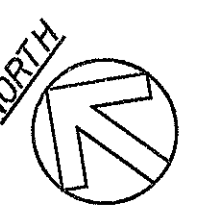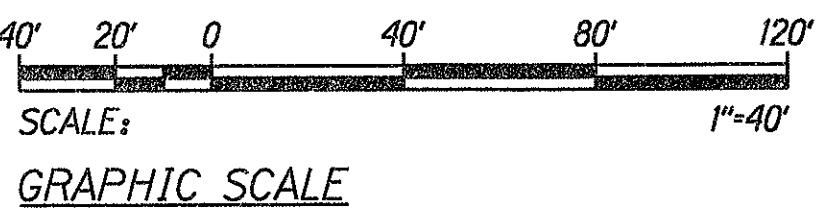


STREET LIGHTING PLAN - VIII
 SCALE: 1"=40'


FED. ROAD DIST. NO.	STATE	FED. AID PROJ. NO.	FISCAL YEAR	SHEET NO.	TOTAL SHEETS
HAWAII	HAW.	IM-H1-1(219)	1998	243	378

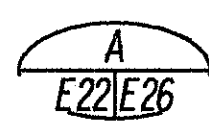- NOTES:
- UTILITY POLE PROVIDED BY RESPECTIVE UTILITY CO.
 - POWER/SIGNAL OVERHEAD LINES PROVIDED BY RESPECTIVE UTILITY CO.
 - OCEANIC CABLE TO INTERCEPT EXISTING CONDUIT AND EXTEND RISER TO RELOCATED POLE.
 - STUB UP 3"C, 6" ABOVE FINISHED GRADE FOR CONNECTION BY HECO.
 - SEE DETAIL 
 - SEE DETAIL 
 - HECO 5' X 7' PULLBOX, VERIFY EXACT LOCATION IN THE FIELD.
 - UNDERGROUND DUCTLINE INSTALLED BY HECO.


- REPLACE EXISTING 240V BALLAST WITH 480V BALLAST. PROVIDE NEW I.D. TAG, SEE SHEET E42.
- INTERCEPT EXISTING DIRECT BURIED CABLE WITH PULLBOX.
- EXTEND CONDUIT, COUPLE TO EXISTING & PROVIDE NEW WIRING AS REQUIRED.
- HECO TO PROVIDE CONDUIT OPENINGS INTO PULLBOX. EXTEND CONDUITS TO PULLBOX AND REPAIR PULLBOX TO MATCH EXISTING CONDITION. COORDINATE LOCATION OF CONDUIT ENTRY INTO PULLBOX WITH HECO.
- CABLES REMOVED BY HECO, ABANDON DUCTLINE IN PLACE.

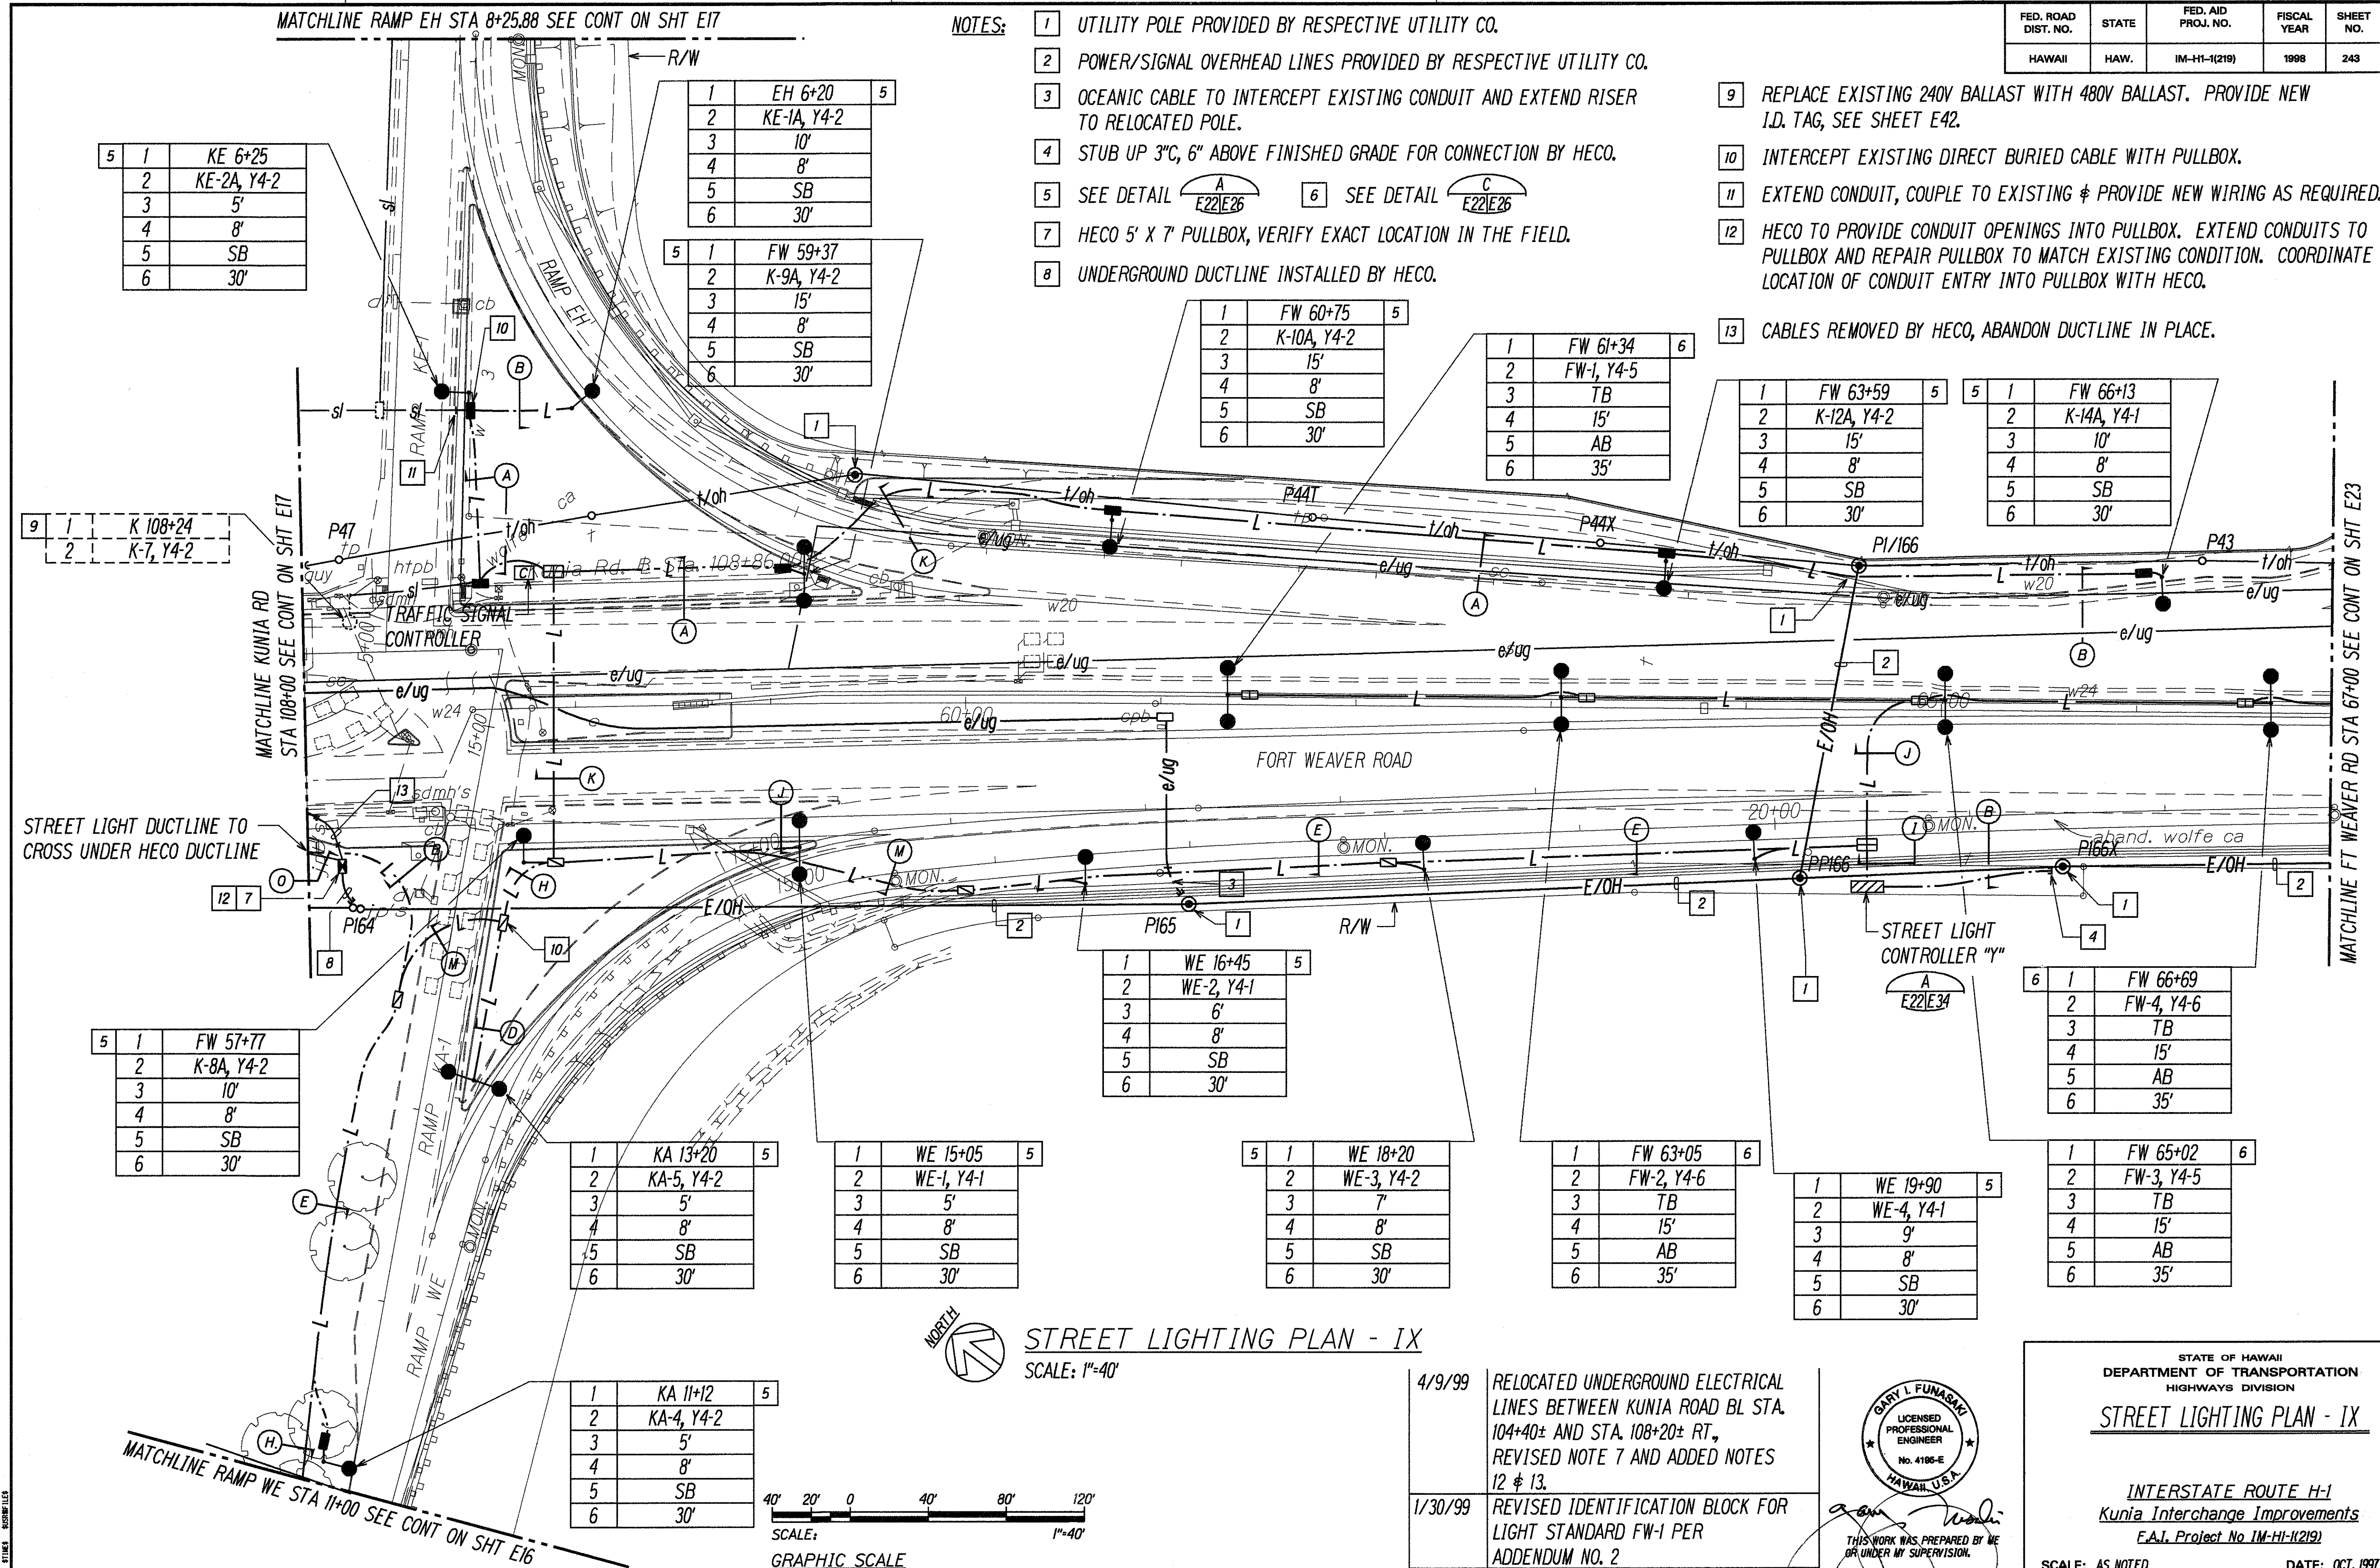

STREET LIGHTING PLAN - IX
SCALE: 1"=40'

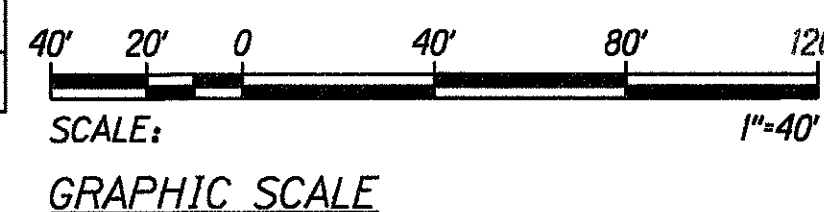

4/9/99	RELOCATED UNDERGROUND ELECTRICAL LINES BETWEEN KUNIA ROAD BL STA. 104+40± AND STA. 108+20± RT., REVISED NOTE 7 AND ADDED NOTES 12 & 13.
1/30/99	REVISED IDENTIFICATION BLOCK FOR LIGHT STANDARD FW-1 PER ADDENDUM NO. 2
DATE	REVISION

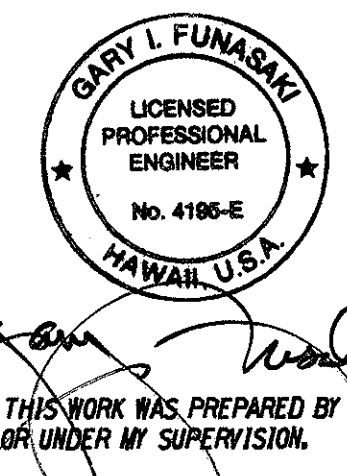


STATE OF HAWAII
DEPARTMENT OF TRANSPORTATION
HIGHWAYS DIVISION

STREET LIGHTING PLAN - IX

INTERSTATE ROUTE H-1
Kunia Interchange Improvements
F.A.I. Project No IM-H1-K219

SCALE: AS NOTED DATE: OCT. 1997
SHEET No. E22 OF 43 SHEETS

FED. ROAD DIST. NO.	STATE	FED. AID PROJ. NO.	FISCAL YEAR	SHEET NO.	TOTAL SHEETS
HAWAII	HAW.	1M-HI-K(219)	1998	244	378

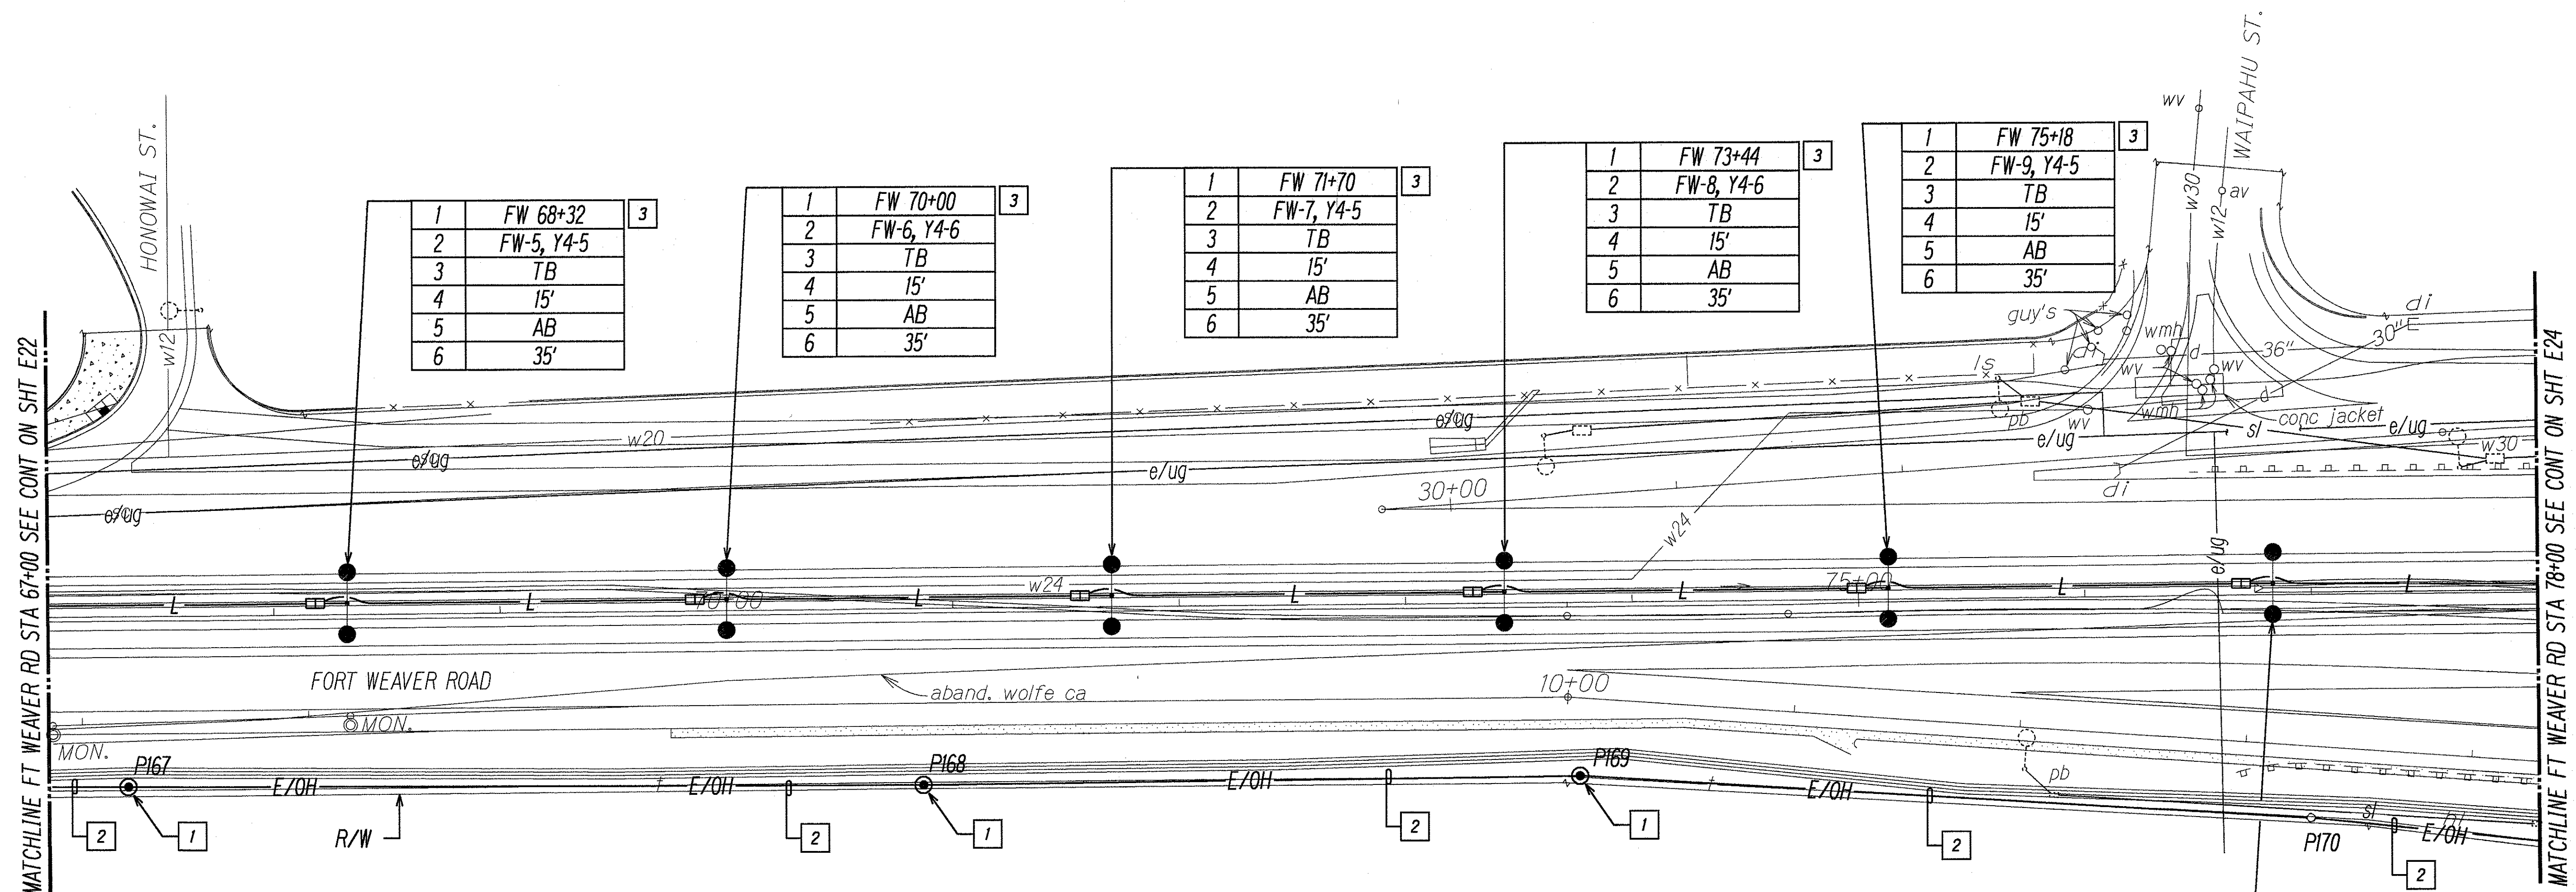

1	FW 68+32	3
2	FW-5, Y4-5	
3	TB	
4	15'	
5	AB	
6	35'	


1	FW 70+00	3
2	FW-6, Y4-6	
3	TB	
4	15'	
5	AB	
6	35'	

1	FW 71+70	3
2	FW-7, Y4-5	
3	TB	
4	15'	
5	AB	
6	35'	

1	FW 73+44	3
2	FW-8, Y4-6	
3	TB	
4	15'	
5	AB	
6	35'	

1	FW 75+18	3
2	FW-9, Y4-5	
3	TB	
4	15'	
5	AB	
6	35'	


3	1	FW 76+83
	2	FW-10, Y4-6
	3	TB
	4	15'
	5	AB
	6	35'

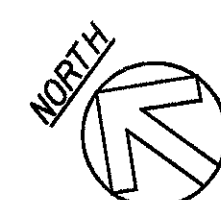

STREET LIGHTING PLAN - X
SCALE: 1"=40'

NOTES:


- 1 UTILITY POLE PROVIDED BY HECO.
- 2 POWER/SIGNAL OVERHEAD LINES PROVIDED BY RESPECTIVE UTILITY CO.
- 3 SEE DETAIL 

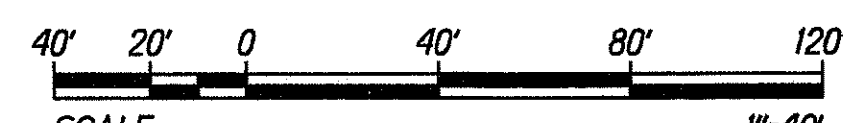

GRAPHIC SCALE

DATE	
SURVEY PLOTTED BY	
ORIGINAL PLAN	
FRAMED BY	
NOTE BOOK	
CHECKED BY	
NO.	

LAST SAVE: 10/10/97 11:43:51 AM BY: GARY L. FUNASAKI
G:\A\PROJECTS\2000\1M-HI-K(219)\E23, E26\DRAWING.DWG

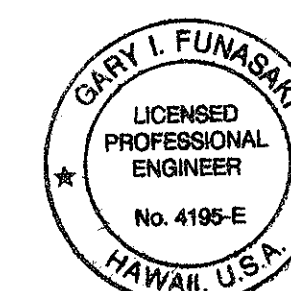


THIS WORK WAS PREPARED BY ME
OR UNDER MY SUPERVISION.
[Signature]
6 NOV 1997

STATE OF HAWAII
DEPARTMENT OF TRANSPORTATION
HIGHWAYS DIVISION
STREET LIGHTING PLAN - X


INTERSTATE ROUTE H-1
Kunia Interchange Improvements
F.A.I. Project No. 1M-HI-K(219)
SCALE: AS NOTED
SHEET No. E23 OF 43 SHEETS
DATE: OCT. 1997

FED. ROAD DIST. NO.	STATE	FED. AID PROJ. NO.	FISCAL YEAR	SHEET NO.	TOTAL SHEETS
HAWAII	HAW.	1M-HI-1(219)	1998	246	378


- NOTES:
- 1 PROVIDE CONCRETE INSERTS FOR MOUNTING STEMS. CONCRETE INSERTS SHALL WITHSTAND A 100 LB PULL-OUT. IMPACT DRILLS SHALL NOT BE USED TO DRILL MOUNTING HOLES. AVOID ALL BRIDGE STRUCTURAL REINFORCING WHEN DRILLING. ALL UNUSED HOLES SHALL BE FILLED WITH EPOXY GROUT.
 - 2 3/4" PVC COATED GRS, 2*10 RHW-USE, #10 GND.

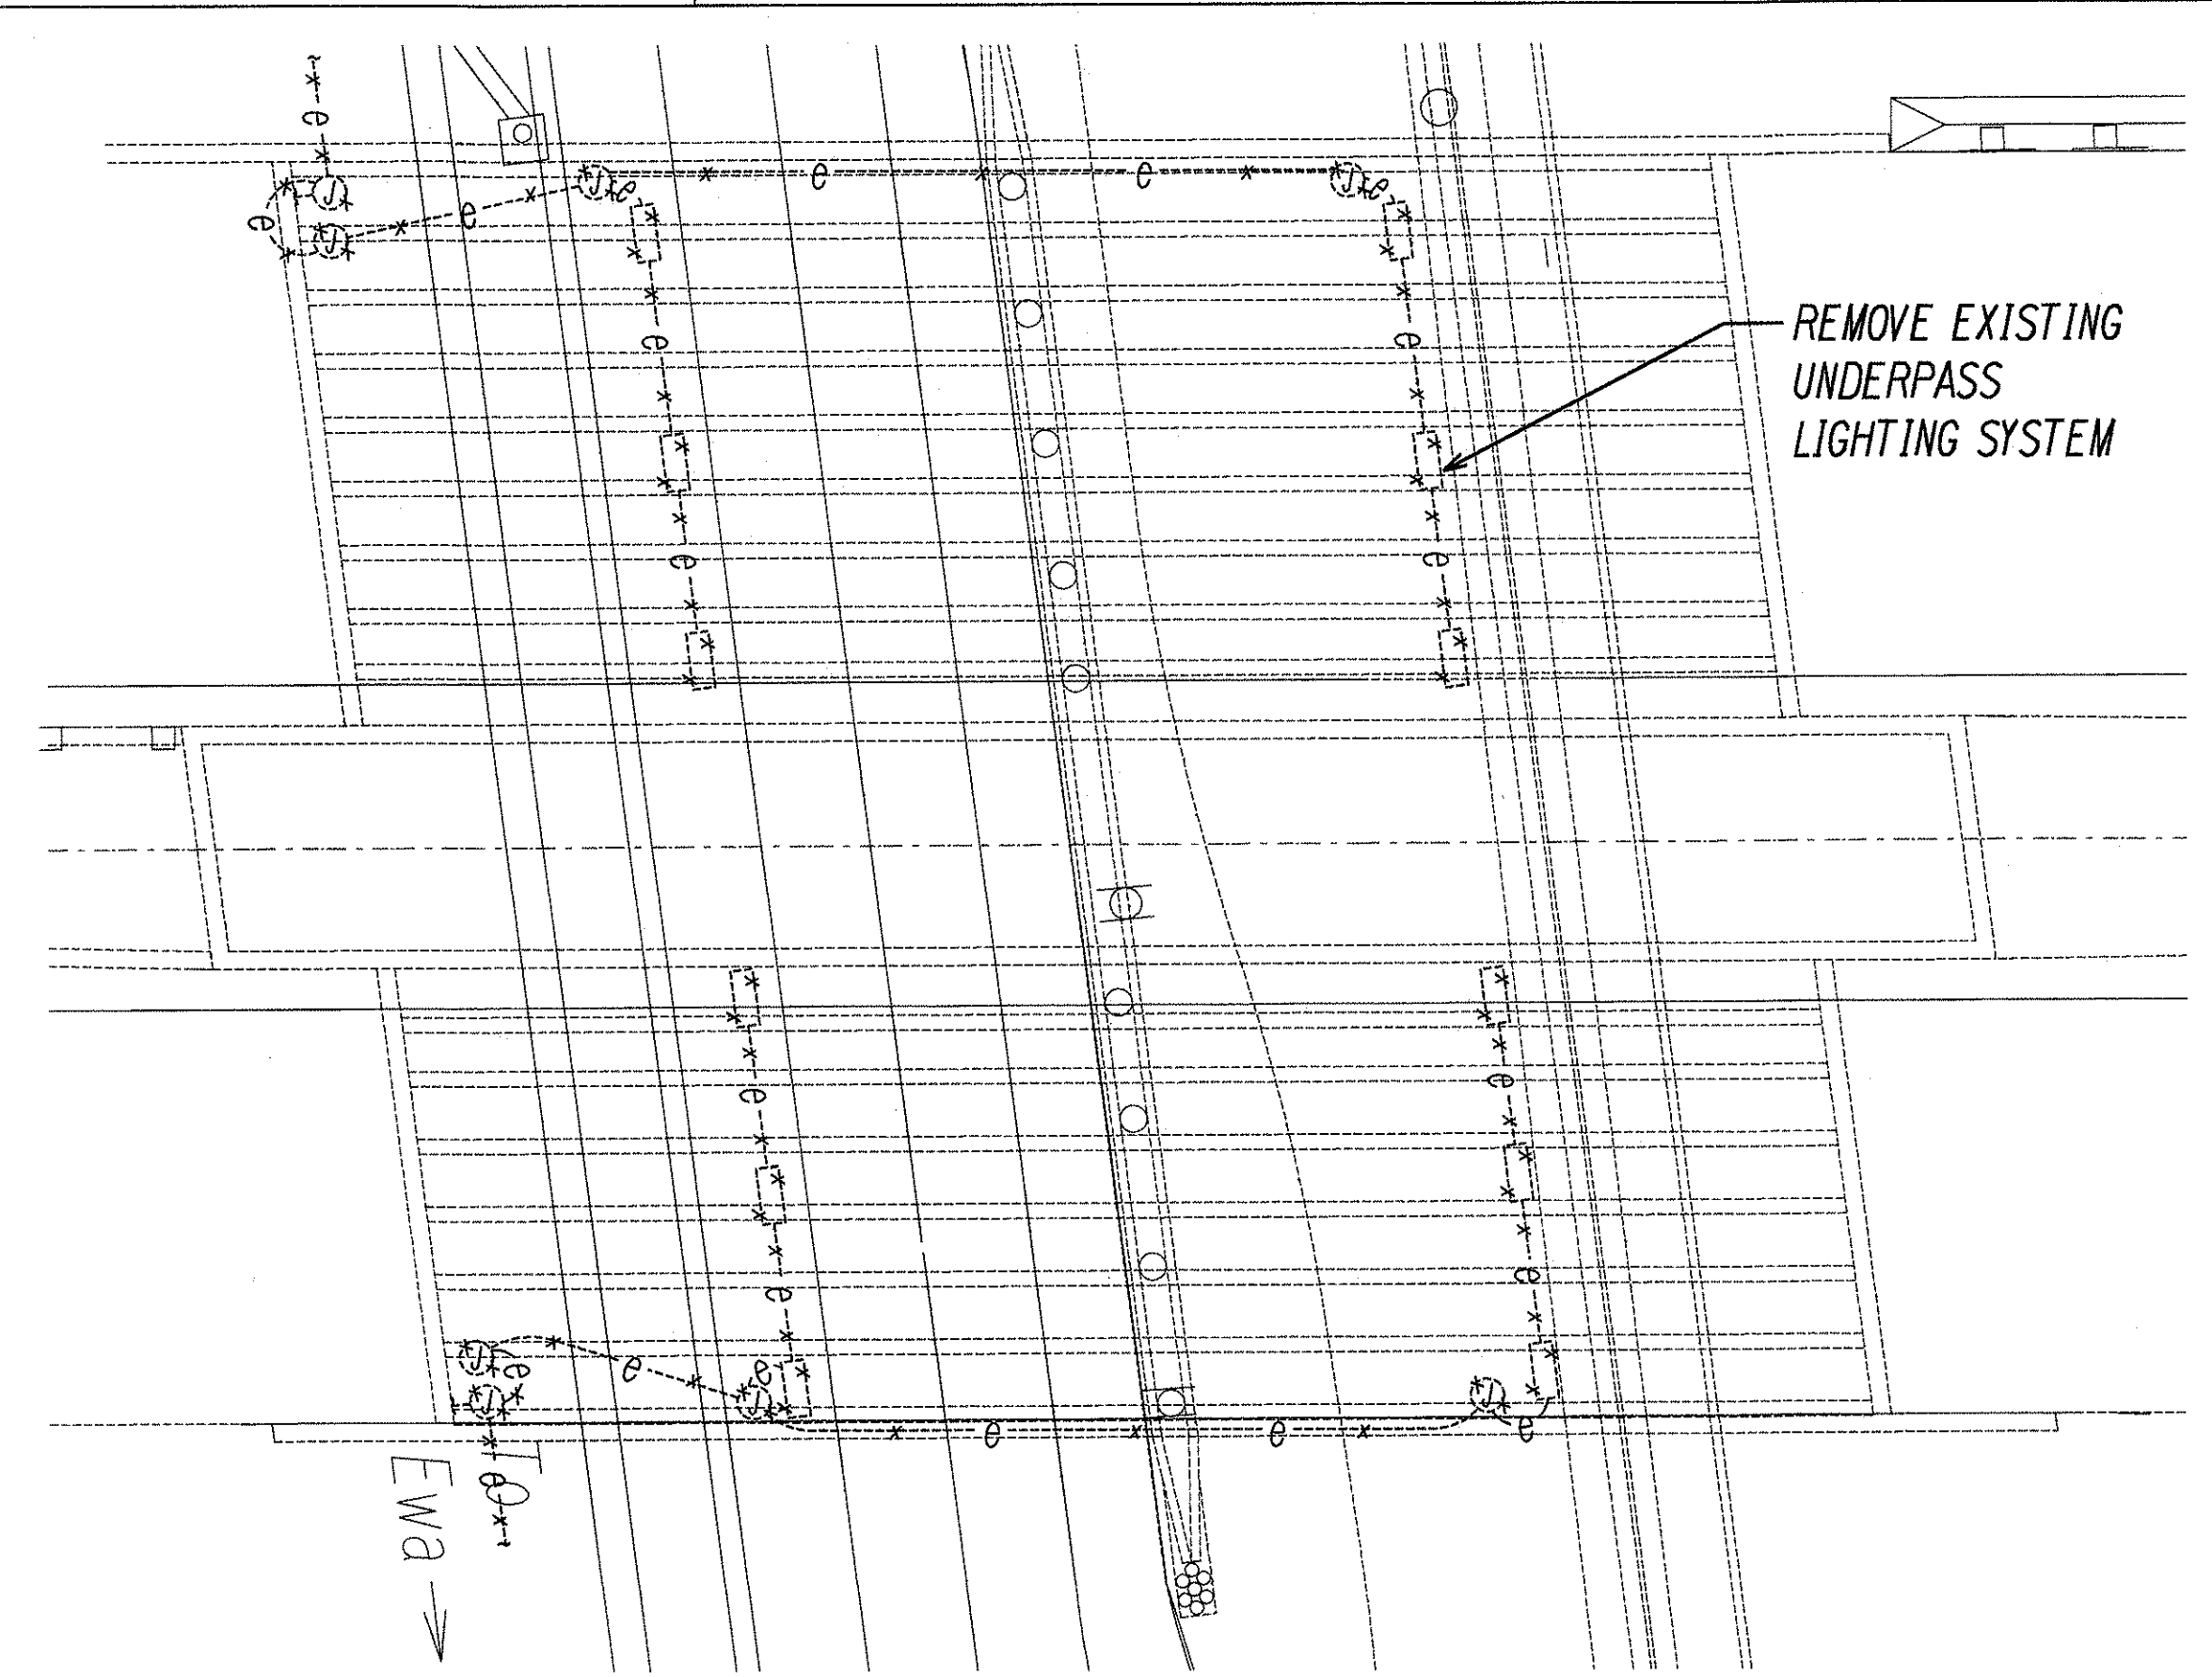

UNDERPASS LIGHTING DEMO PLAN
SCALE: 1"=20'-0"

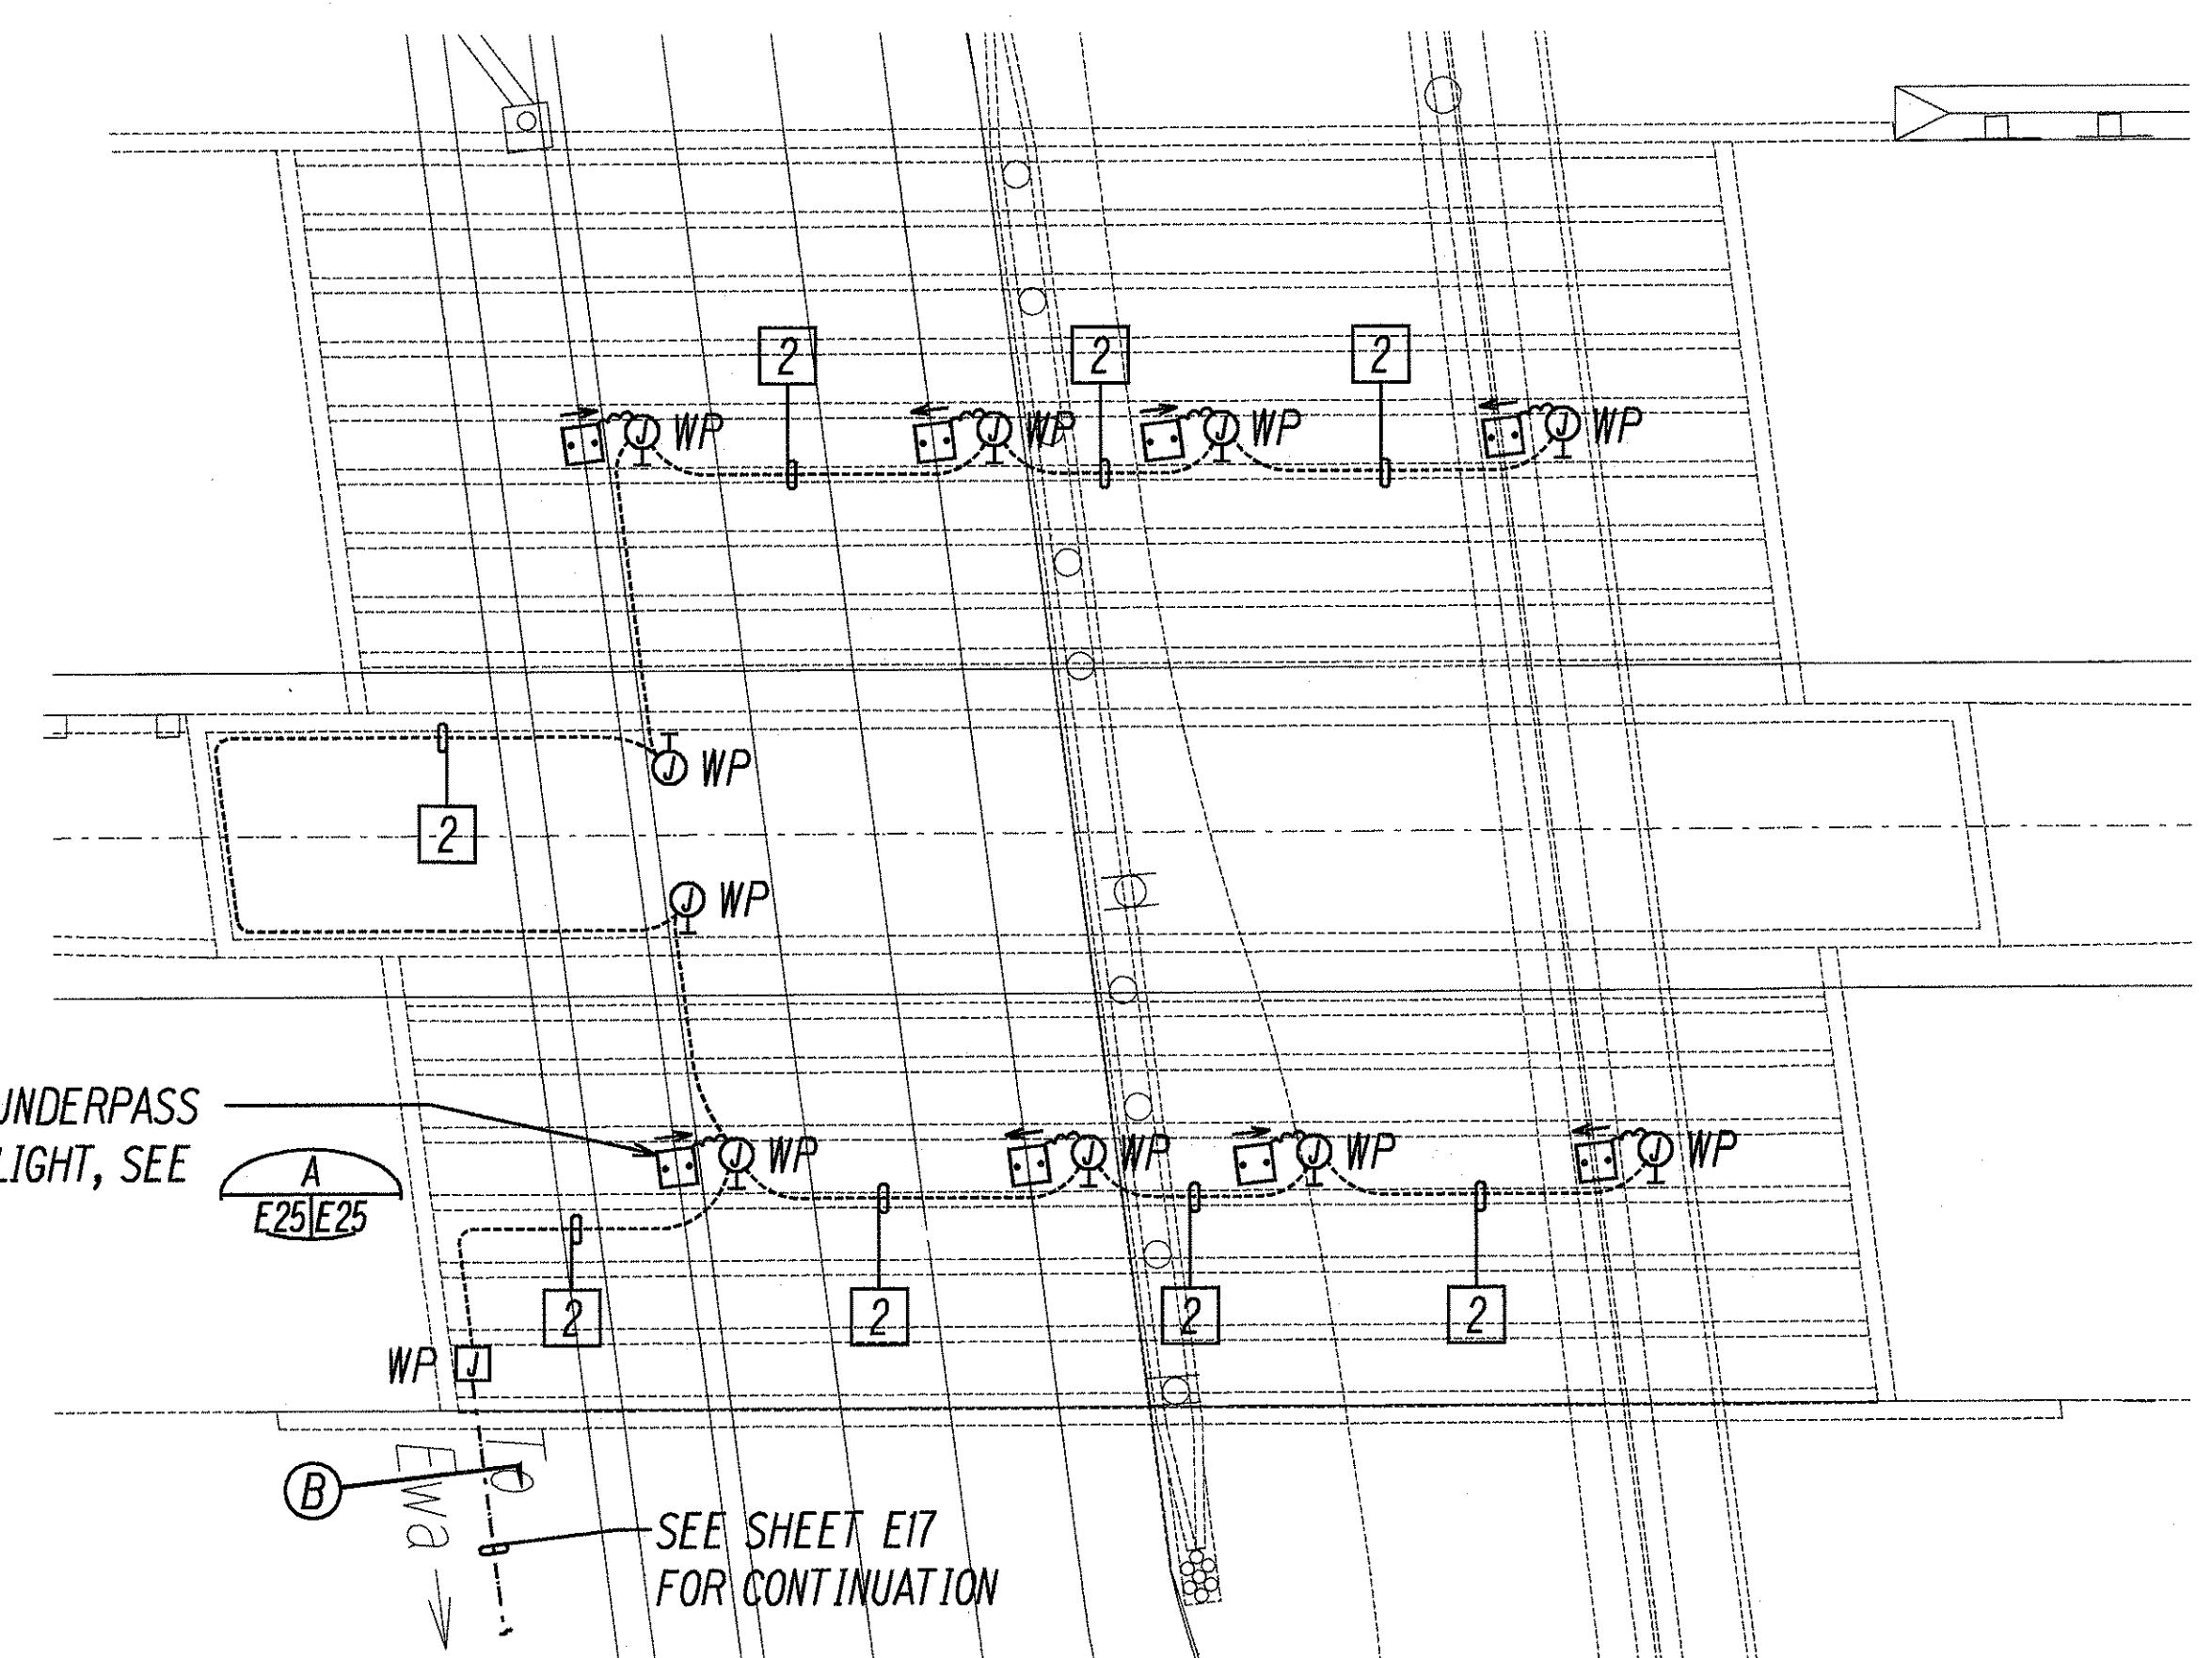


UNDERPASS LIGHTING PLAN
SCALE: 1"=20'-0"

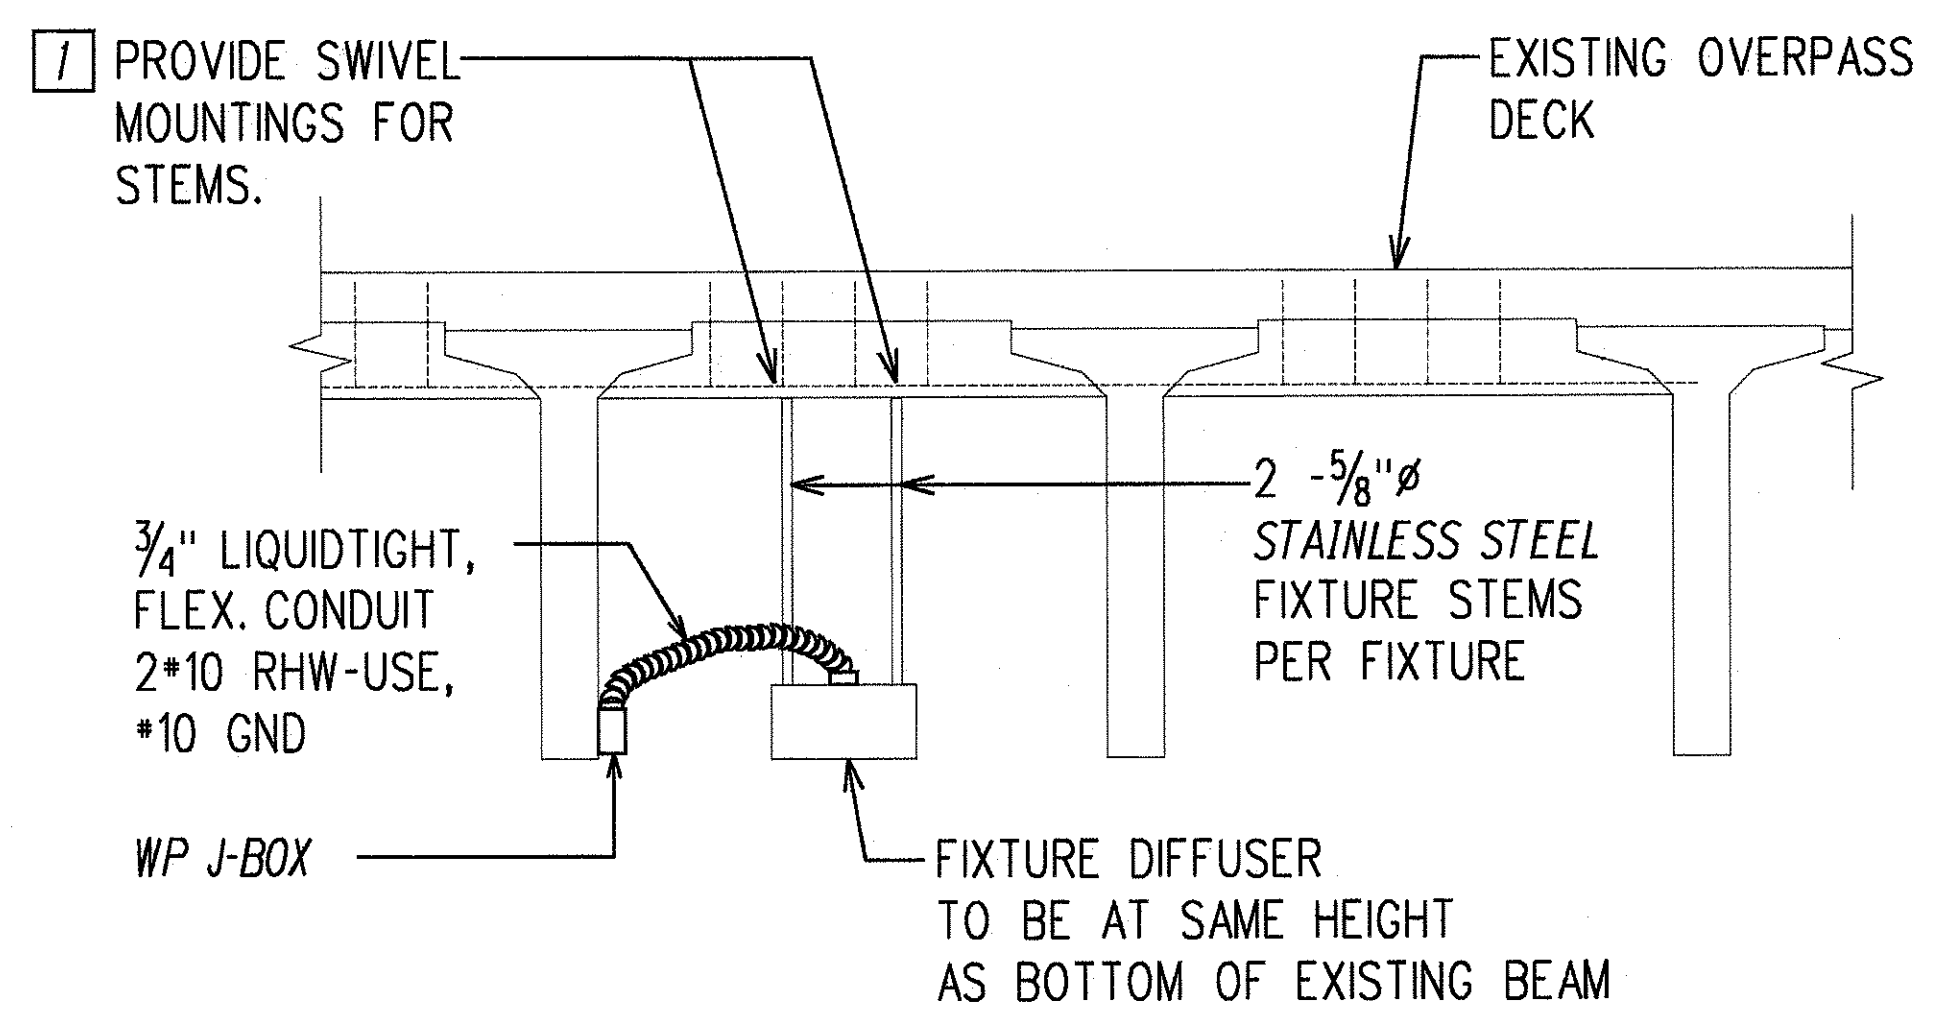


NOTE: ALL CEILING INSERTS FOR FIXTURE MOUNTING HARDWARE SHALL WITHSTAND A 100 LB PULL-OUT.

A TYPICAL UNDERPASS LIGHT FIXTURE. MTG. DETAIL
E25/E25 NOT TO SCALE

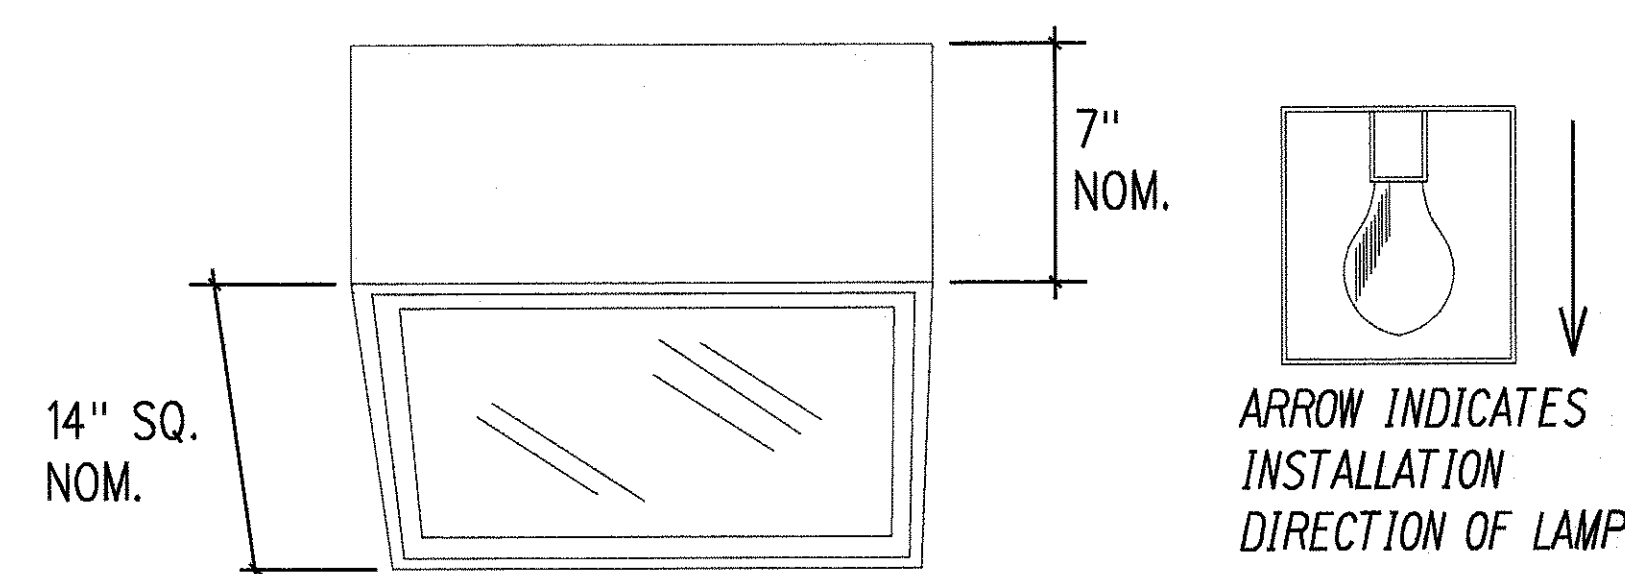


LAMP: 100W HPS, CLEAR
DESCRIPTION: EXTRUDED ALUMINUM CHASSIS WITH MITERED, WELDED CORNERS, DARK BRONZE ANODIZED FINISH, U.L. LISTED FOR WET LOCATIONS, CLEAR, TEMPERED GLASS DIFFUSER, HYDROFORMED SPECULAR ALUMINUM REFLECTOR WITH IES TYPE II OPTICS, HPF, CONSTANT WATTAGE AUTOTRANSFORMER BALLAST. AS A STANDARD FEATURE, FIXTURE SHALL BE SUITABLE FOR STEM MOUNTING.

B UNDERPASS LIGHT FIXTURE DETAIL
E25/E25 NOT TO SCALE

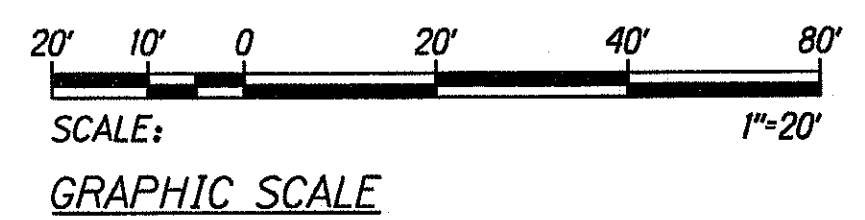

DATE: _____
SURVEY PLOTTED BY: _____
ORIGINAL PLAN: _____
DESIGNED BY: _____
NOTE BOOK: _____
QUANTITIES BY: _____
CHECKED BY: _____
LAST SHEET: 246 OF 378 SHEETS
DATE: OCT. 1997

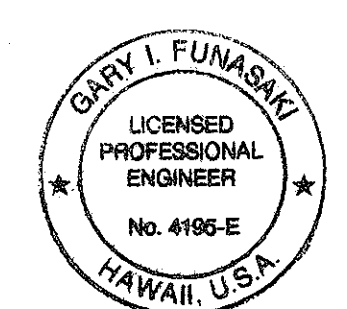











THIS WORK WAS PREPARED BY ME OR UNDER MY SUPERVISION.
DATE: OCT. 1997
6 NOV 1997

STATE OF HAWAII
DEPARTMENT OF TRANSPORTATION
HIGHWAYS DIVISION

UNDERPASS LIGHTING DEMO PLAN, UNDERPASS LIGHTING PLAN

INTERSTATE ROUTE H-1
Kunia Interchange Improvements
F.A.I. Project No 1M-HI-1(219)
SCALE: AS NOTED DATE: OCT. 1997
SHEET No. E25 OF 43 SHEETS

FED. ROAD DIST. NO.	STATE	FED. AID PROJ. NO.	FISCAL YEAR	SHEET NO.	TOTAL SHEETS
HAWAII	HAW.	1M-HI-1(219)	1998	248	378

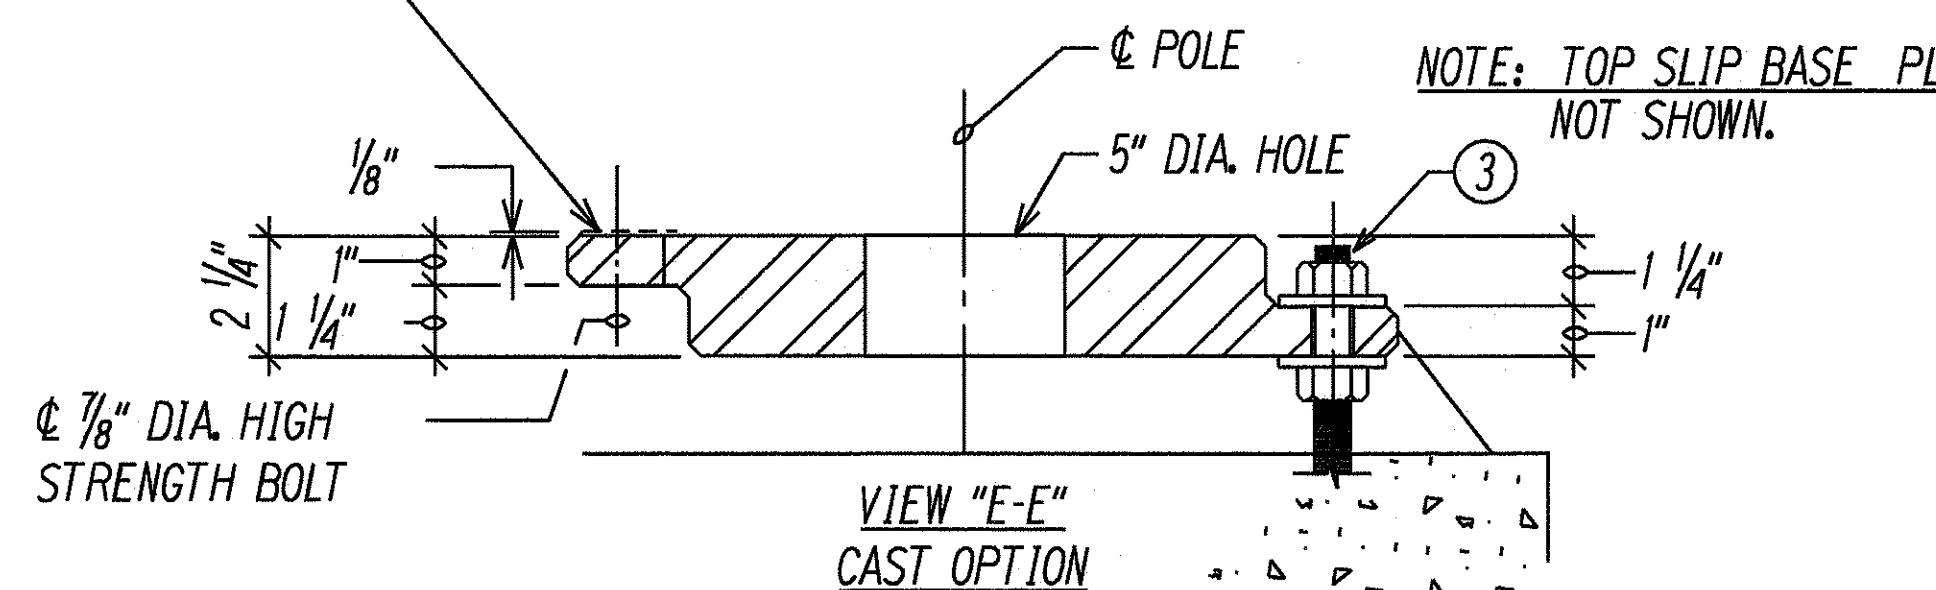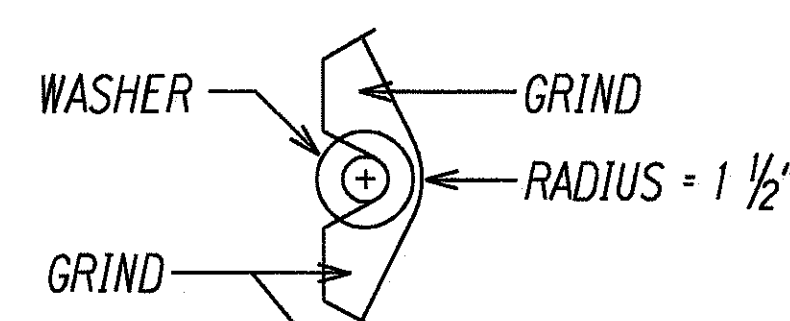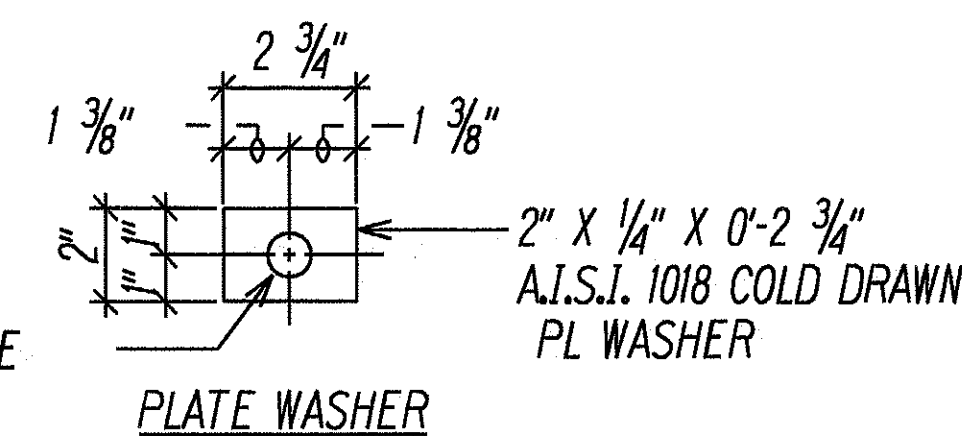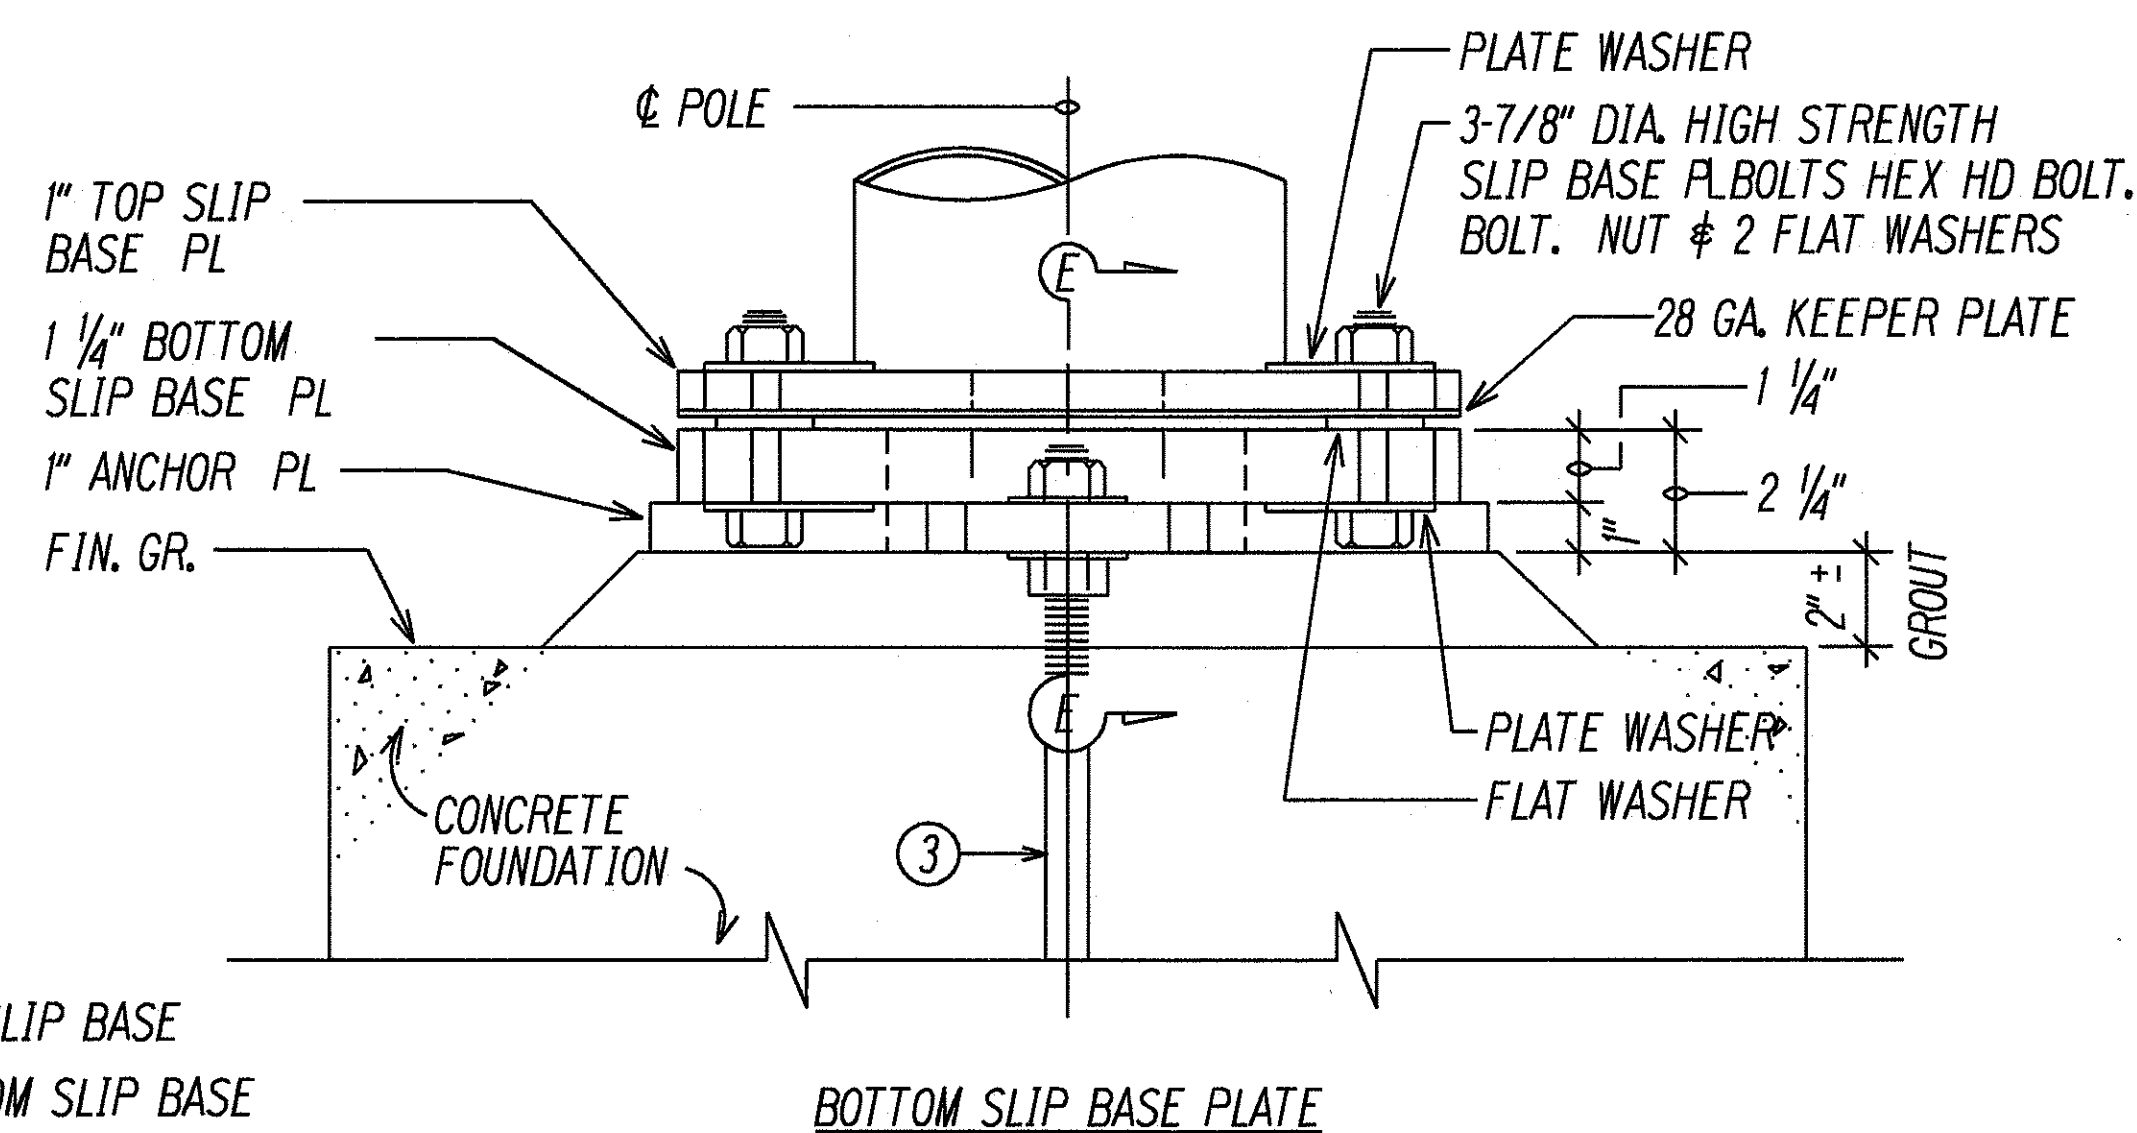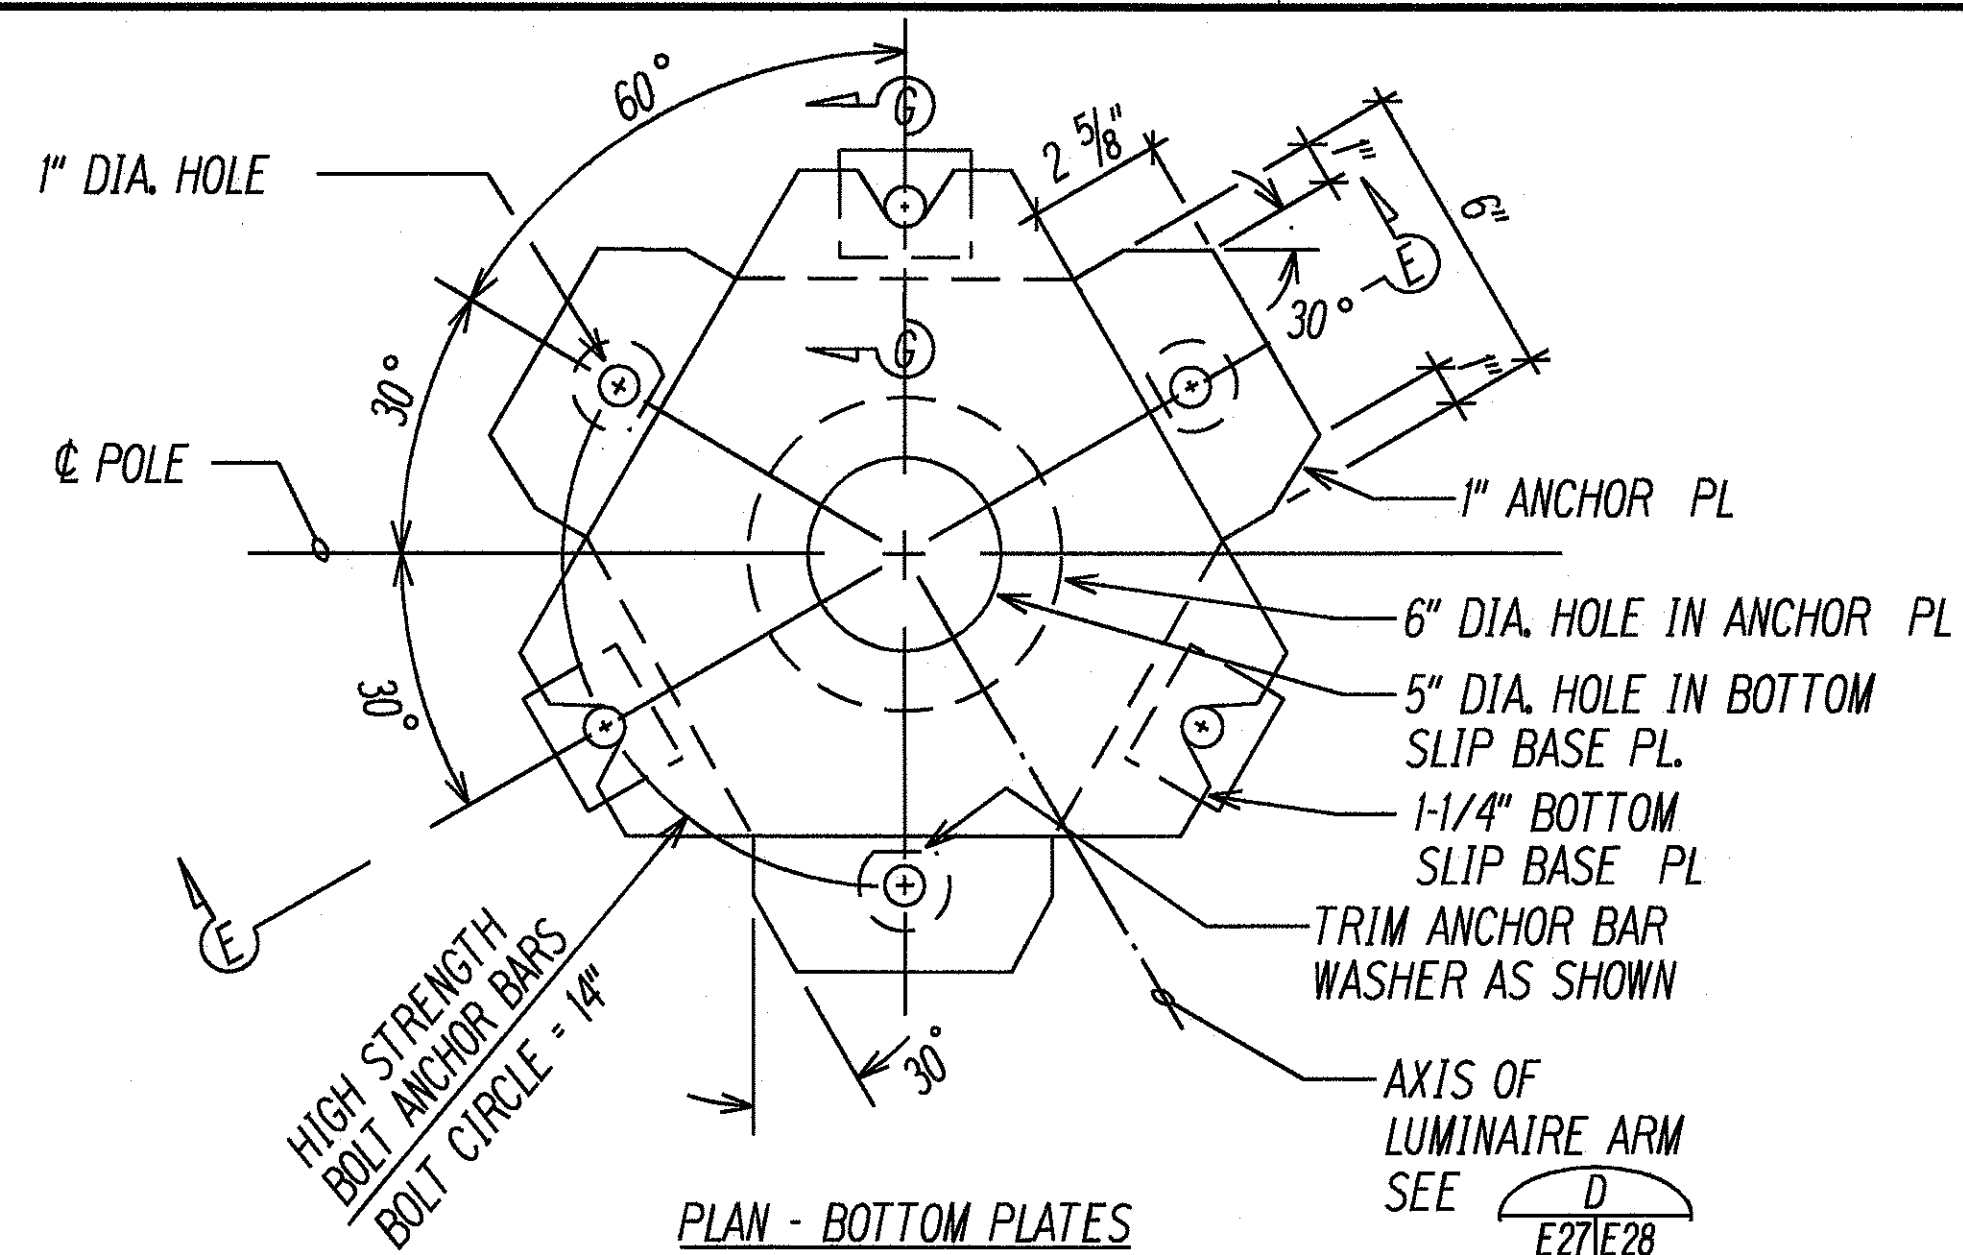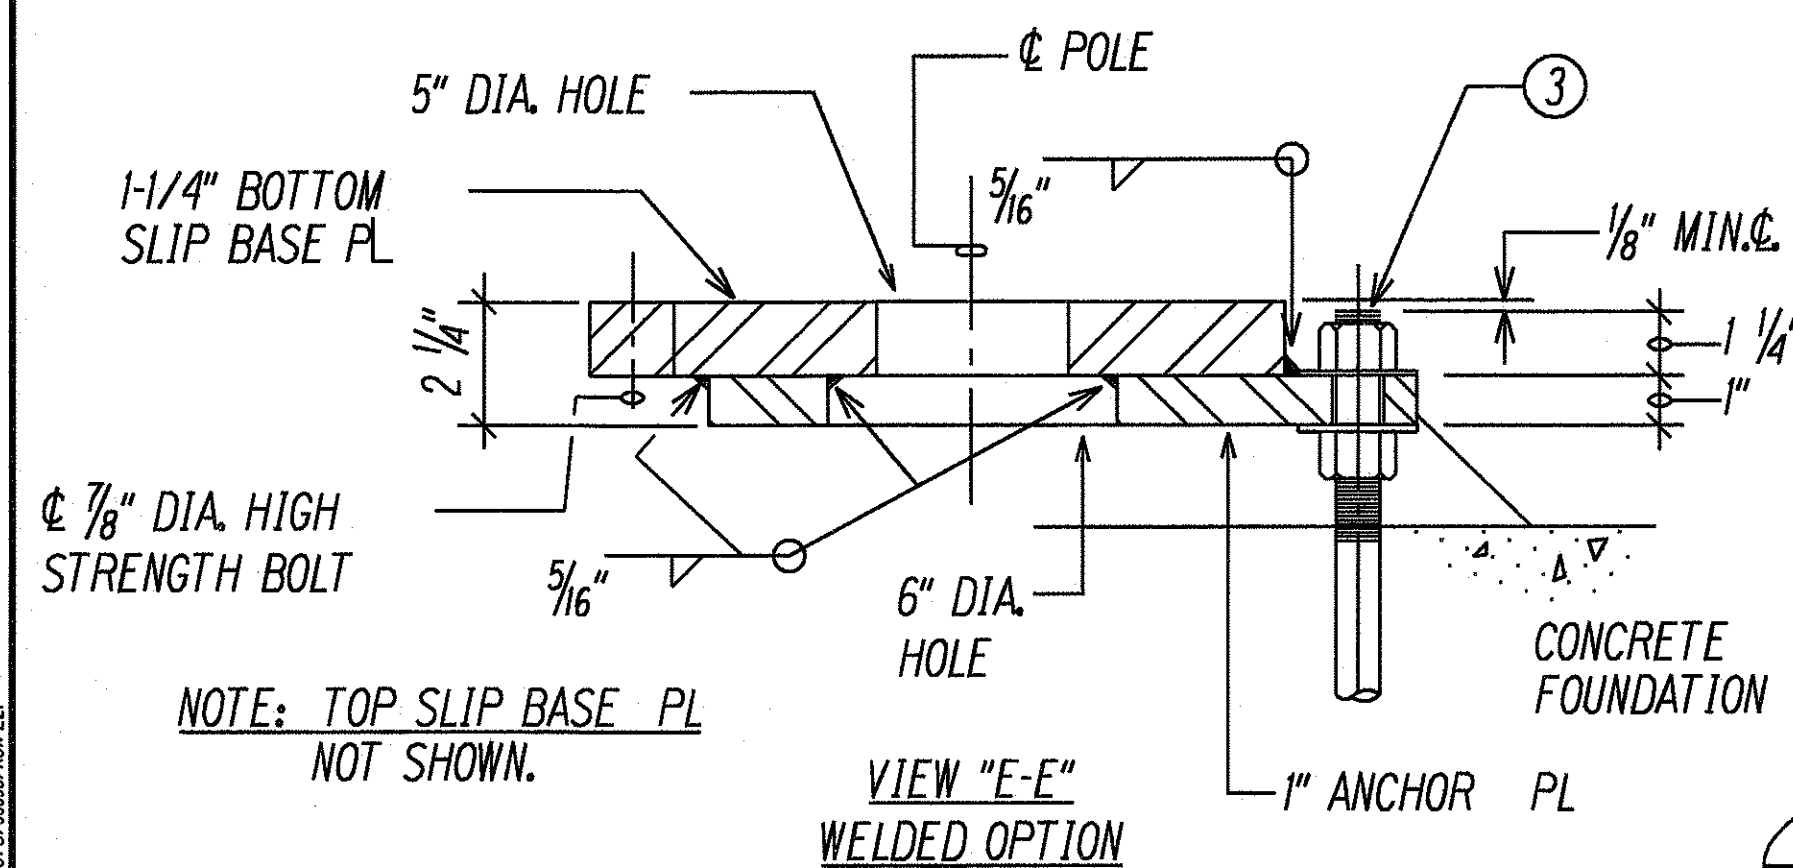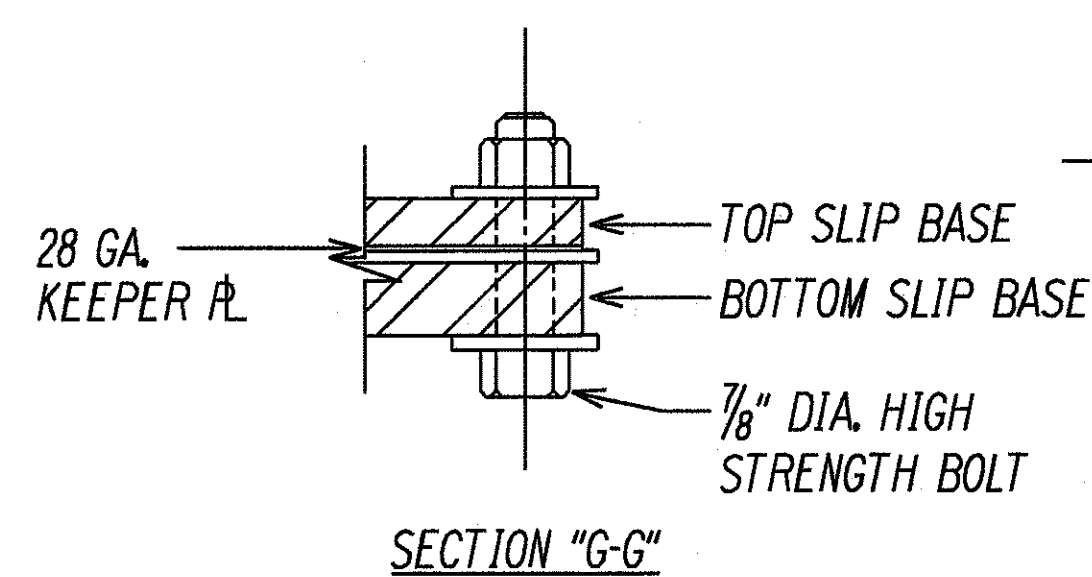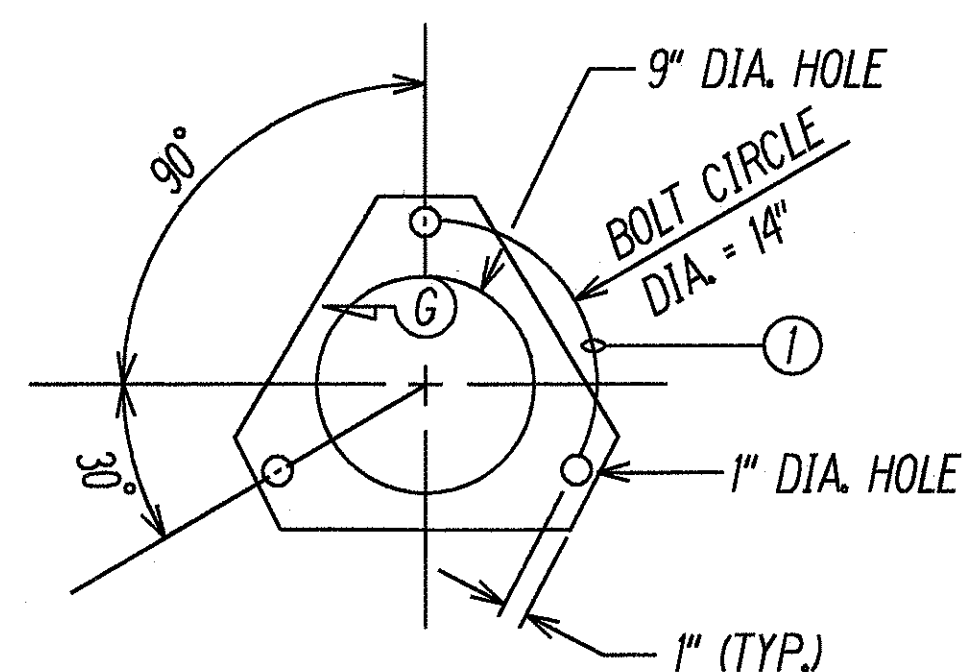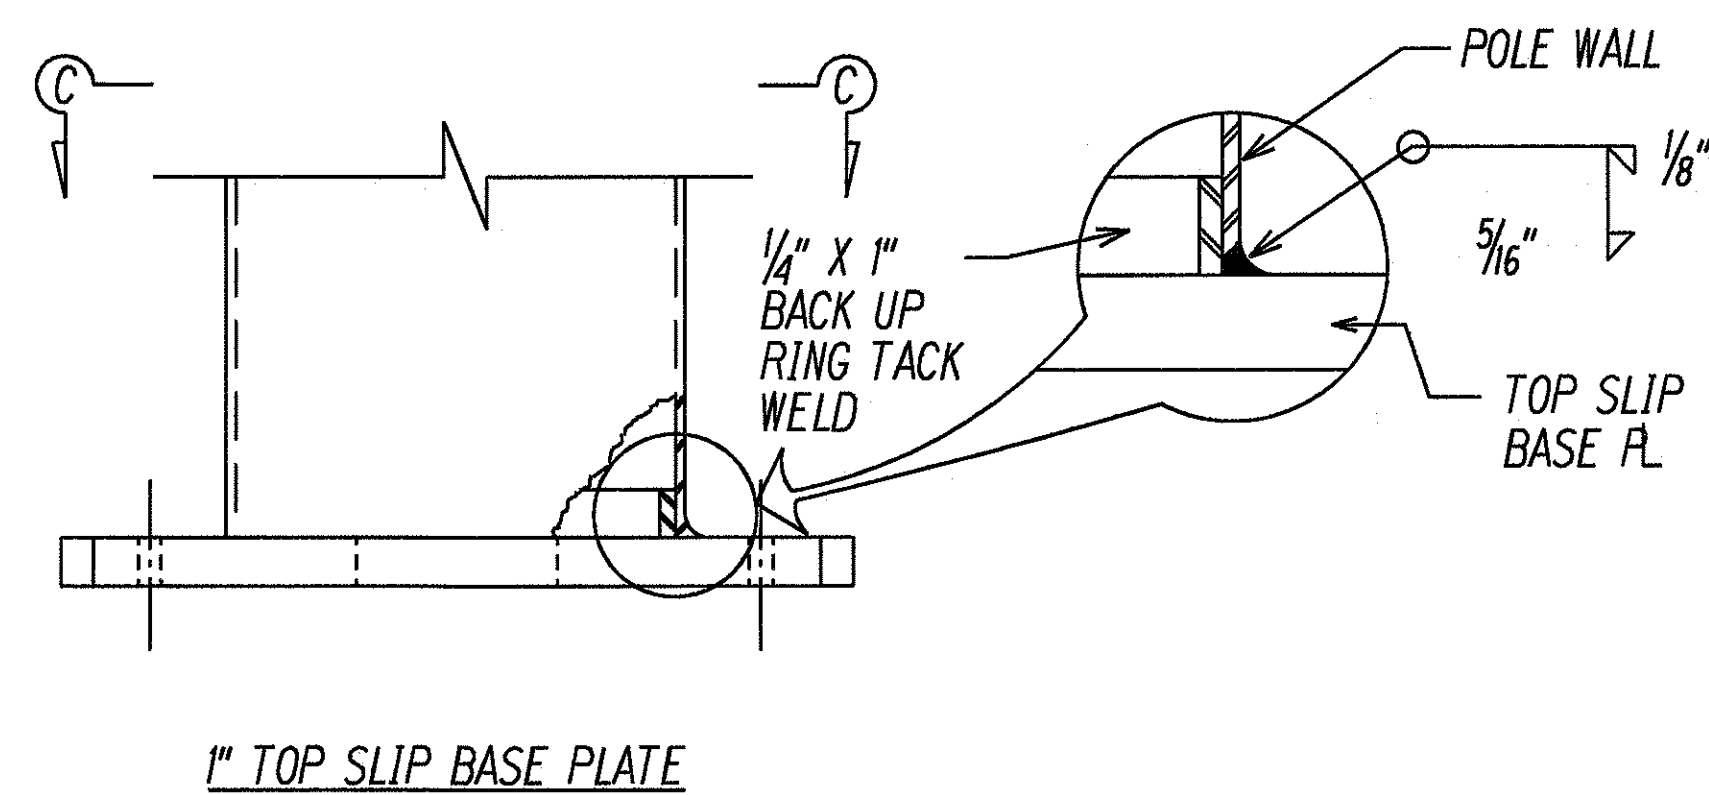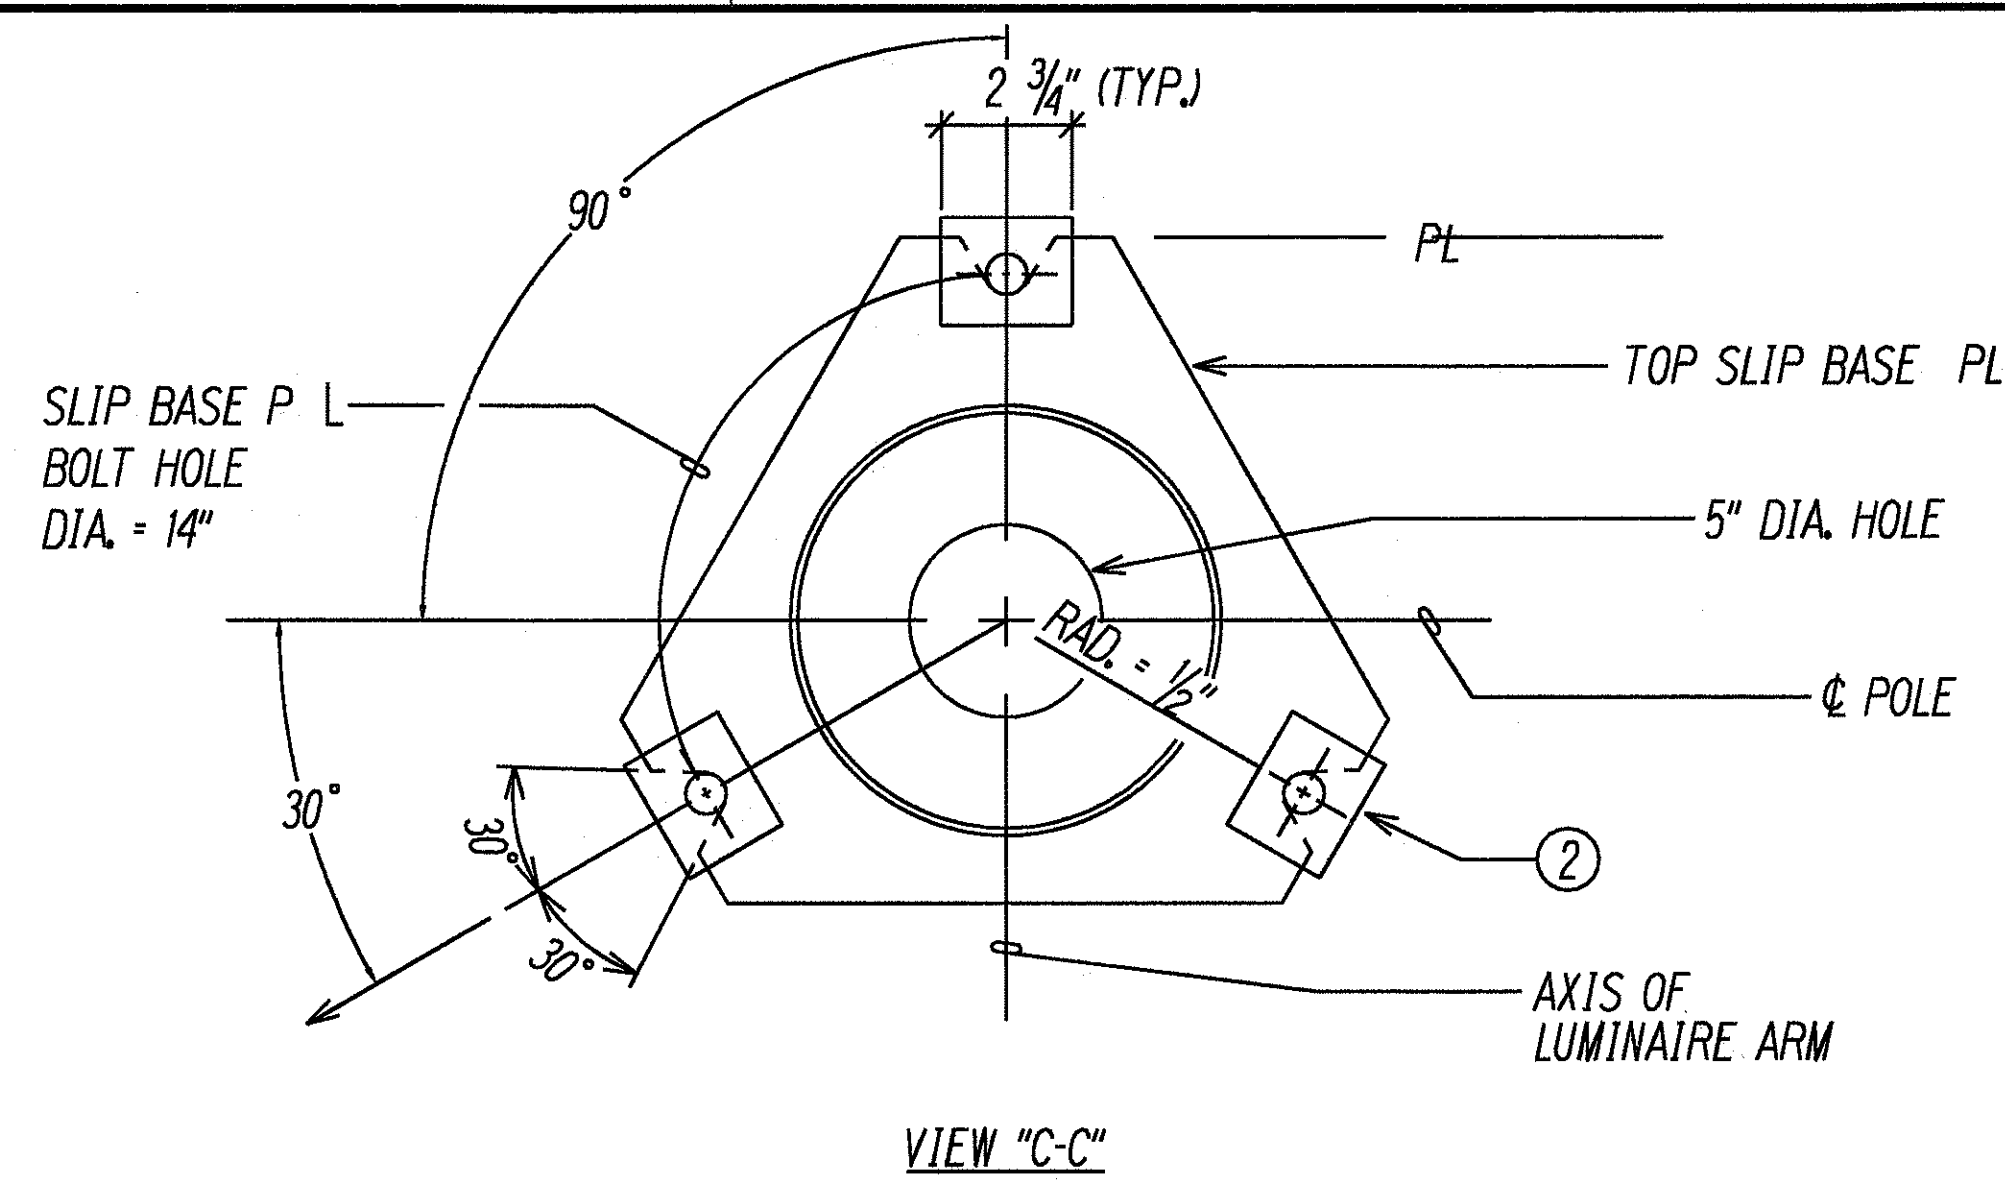

NOTES:

- 28 GAUGE KEEPER PLATE, PLACE ON TOP OF MIDDLE FLAT WASHER, ASTM A-526 125 COMMERCIAL.
- PLATE WASHER.
- 3 - 7/8" DIAMETER HIGH STRENGTH BARS, THREAD 6" & GALVANIZED 10', WITH HEX. HEAD, NUT, LEVELING NUT & WASHER.


GENERAL NOTES:

- ALL PLATES, BOLTS, SCREWS, NUTS & WASHERS TO BE HOT-DIPPED GALVANIZED AFTER FABRICATION OR MODIFICATION.
- PLATES TO CONFORM TO ASTM A-36.
- CAST OPTION TO CONFORM TO ASTM A-486 CL. 90.
- TORQUE 7/8" DIAMETER HIGH STRENGTH SLIP BASE PLATE BOLTS TO 84 FEET PER POUND.
- 7/8" DIAMETER H.S. ANCHOR BARS, WRENCH TIGHTEN - TORQUE REQUIREMENT WAIVED.
- FABRICATORS ELECTING LARGER THAN MINIMUM ARM DIAMETERS MUST ADJUST DETAILS AS REQUIRED TO PERMIT SOLID SEATING OF CAP SCREWS. IN LIEU OF TORQUE REQUIREMENTS FOR HIGH STRENGTH BOLTS, CAP SCREWS SHALL BE TIGHTENED BY THE TURN OF NUT METHOD 1/6 TURN FROM SNUG CONDITION. NO WASHER WILL BE REQUIRED.
- 4" X 6 1/2" HANDHOLE REINFORCED WITH #3 GAUGE RING 1/2" WIDE WELDED TO OUTSIDE OF POLE COVER OF 10 GAUGE PLATE LOCATE 180 DEGREES OF MAST ARM UNLESS SHOWN OTHERWISE.
- HEX. HEAD NUT SHOWN OR AS AN ALTERNATE DETAIL ANCHOR PLATES MAY BE RETAINED WITH 5/16" FILLET WELDS ALL AROUND OR FORMED HEADS.
- MINIMUM THICKNESS OF STEEL TO BE PER MANUFACTURER'S DESIGN BASED ON POLE AND ARM WITHSTANDING AASHTO 100 MPH WIND.
- MANUFACTURER'S FABRICATION DRAWINGS TO BE STAMPED AND SIGNED BY LICENSED PROFESSIONAL ENGINEER.

SURVEY PLOTTED BY	DATE
DRAWN BY	
CHECKED BY	
NOTE BOOK	
CHECKED BY	
LAST SAVE: 10/01/98	DESIGN BY: 10/01/98
PROJECT: 10/01/98	PROJECT: 10/01/98

LAST SAVE: 10/01/98
DESIGN BY: 10/01/98
PROJECT: 10/01/98

A
E28/E27
SLIP BASE DETAILS
N.T.S.

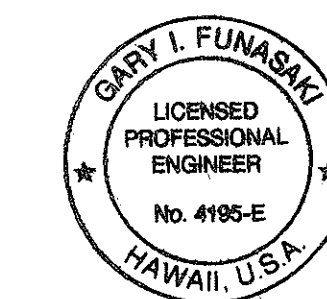


THIS WORK WAS PREPARED BY ME
OR UNDER MY SUPERVISION.
6 NOV 1997

STATE OF HAWAII
DEPARTMENT OF TRANSPORTATION
HIGHWAYS DIVISION
STREET LIGHT SLIP BASE DETAIL

INTERSTATE ROUTE H-1
Kunia Interchange Improvements
F.A.I. Project No 1M-HI-1(219)


SCALE: AS NOTED
DATE: OCT. 1997
SHEET No. E27 OF 43 SHEETS

FED. ROAD DIST. NO.	STATE	FED. AID PROJ. NO.	FISCAL YEAR	SHEET NO.	TOTAL SHEETS
HAWAII	HAW.	1M-HI-1(219)	1998	249	378

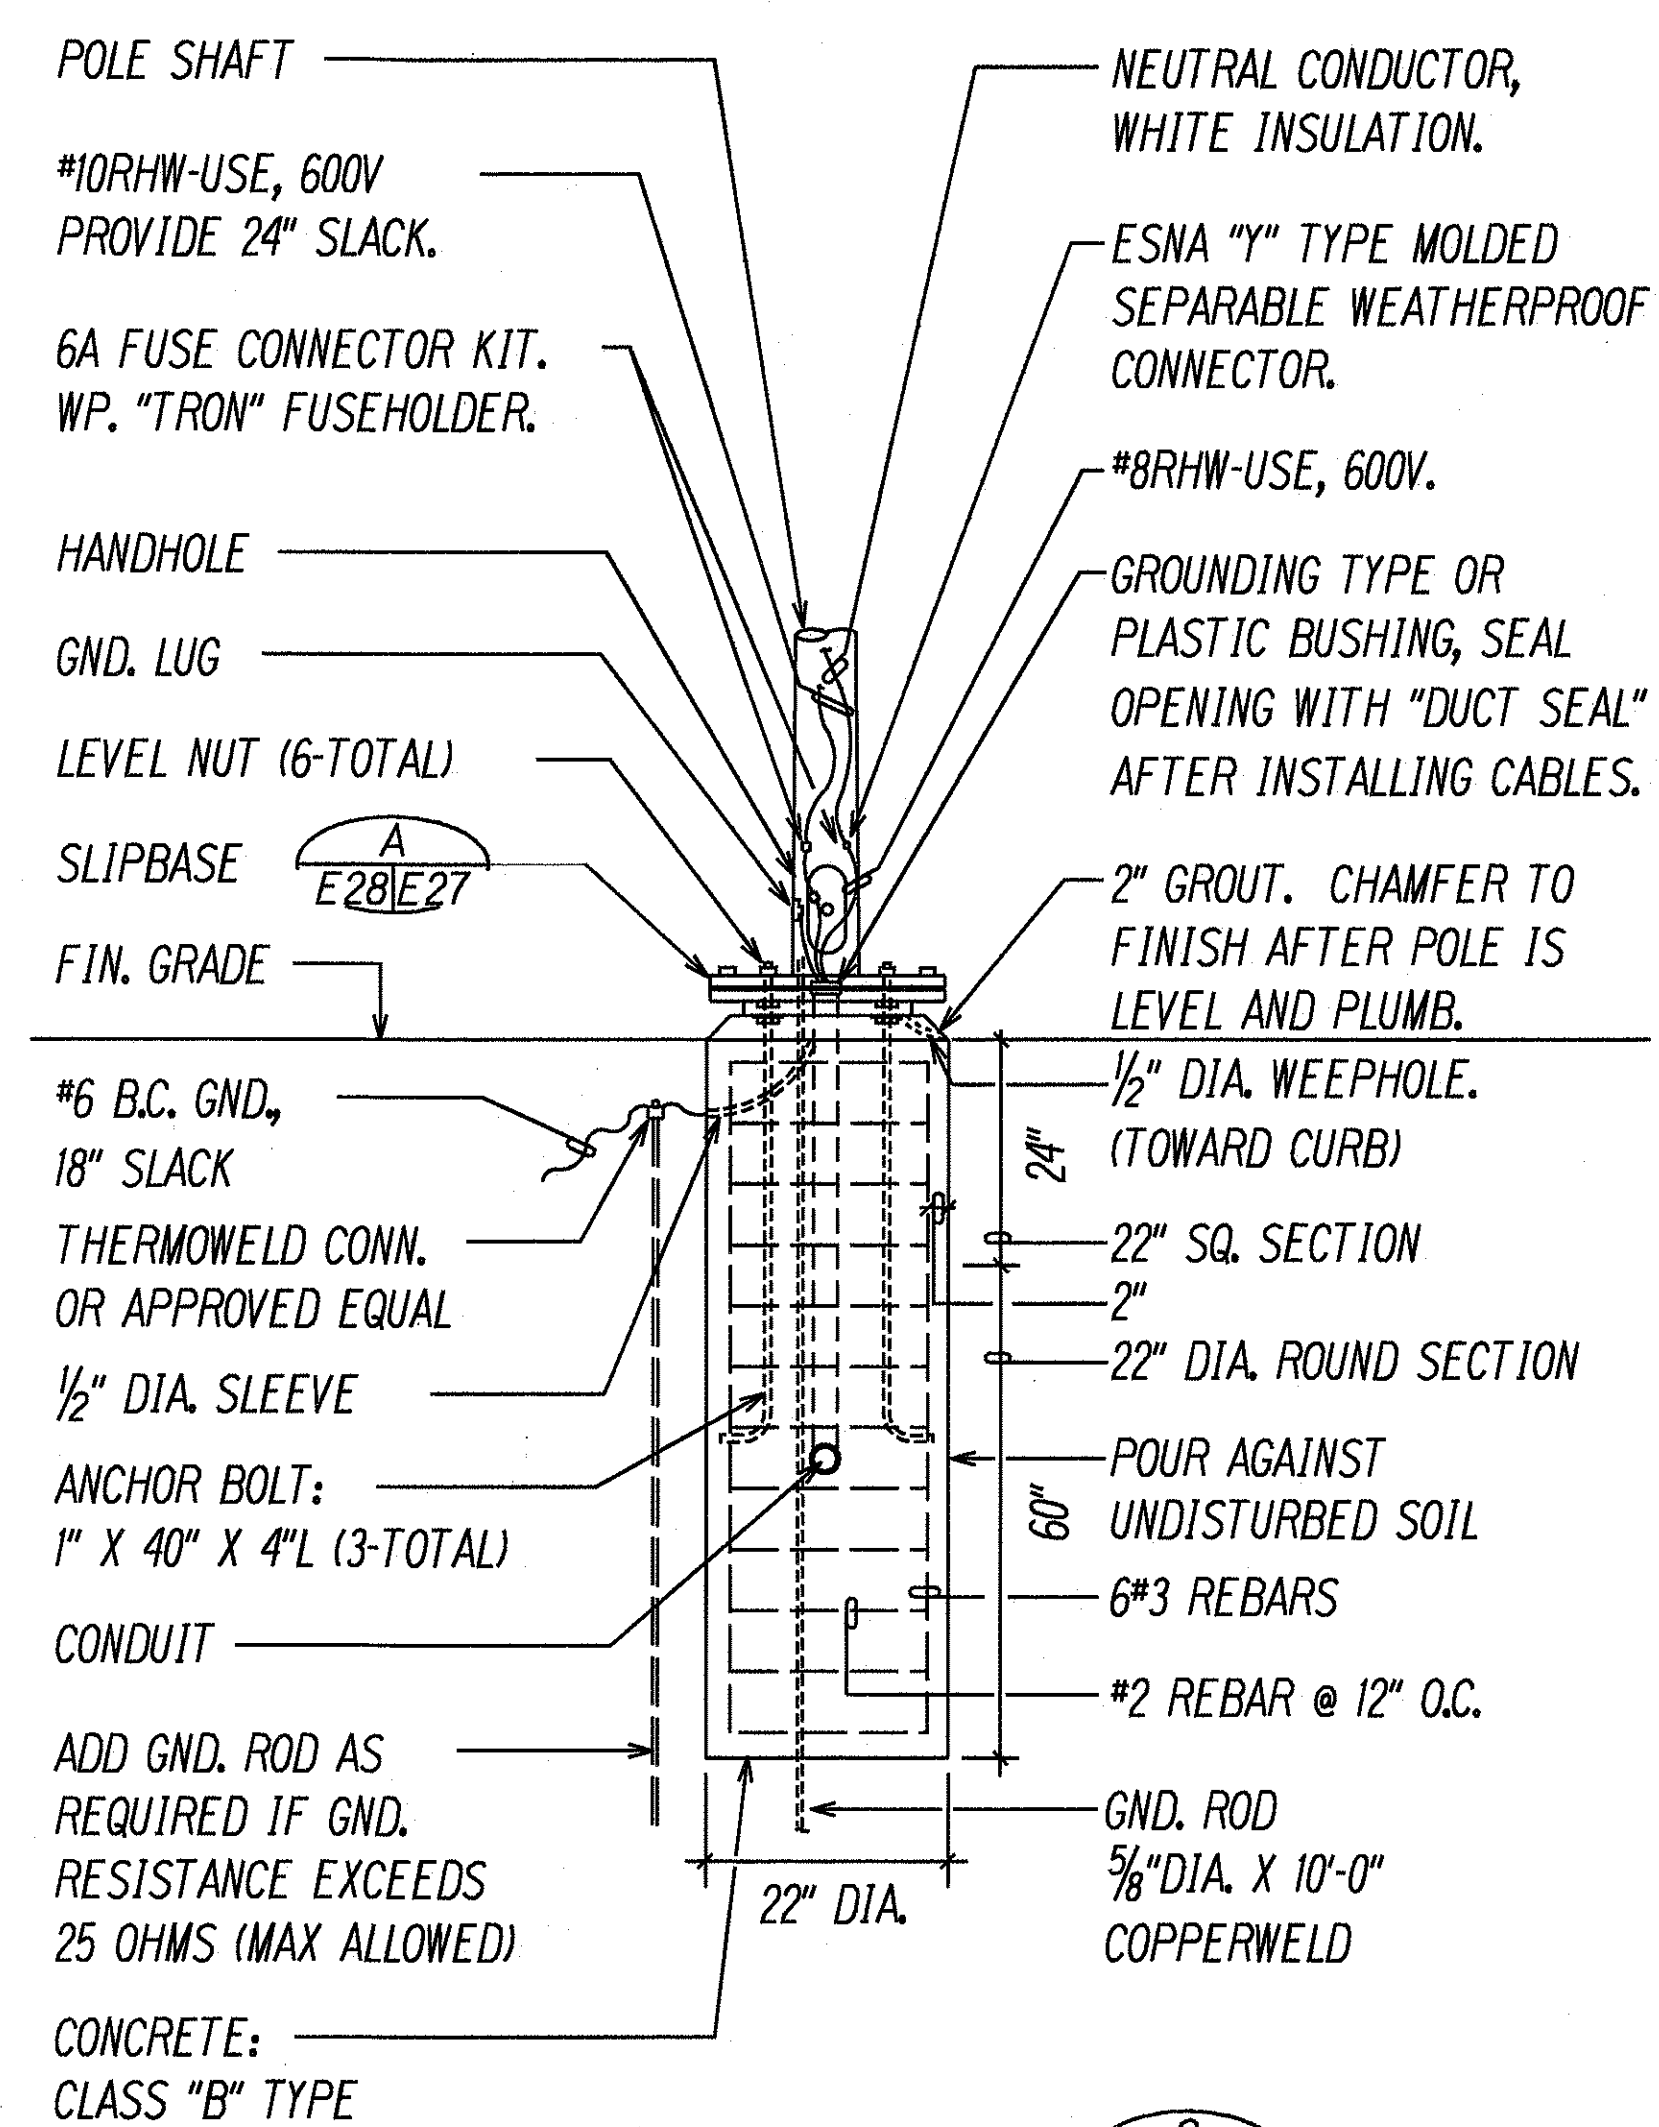

NOTE: SEE DETAILS C
E28/E28

A
E26/E28 CONCRETE SLIP BASE ELEVATION
NOT TO SCALE


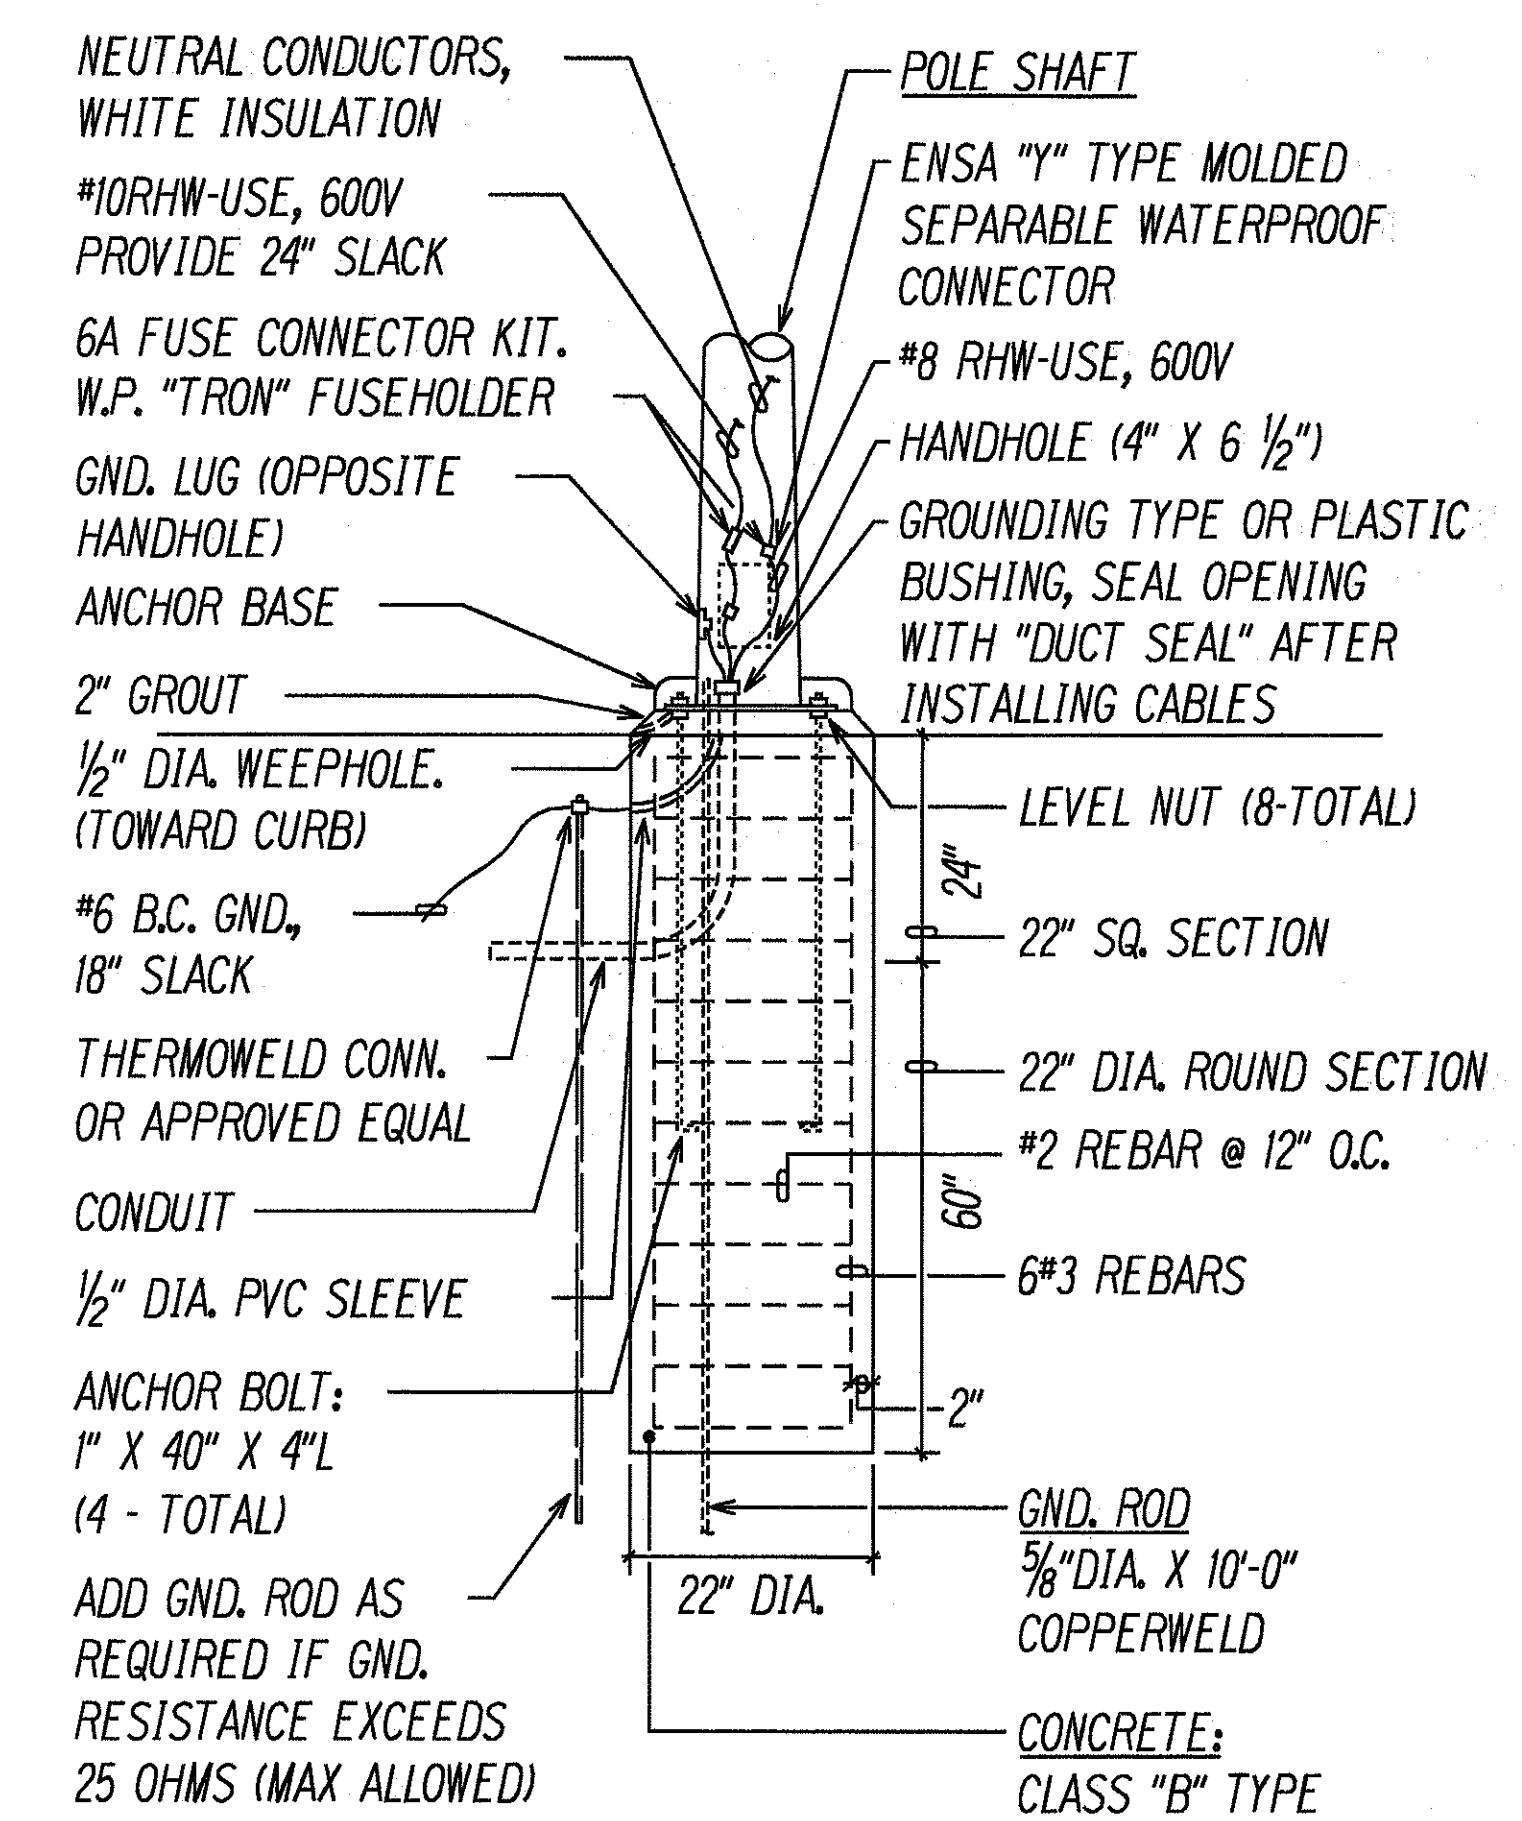


NOTE: SEE DETAILS C
E28/E28


B
E26/E28 CONCRETE ANCHOR BASE ELEVATION
NOT TO SCALE

GENERAL STREET LIGHT NOTES:


1. CONTRACTOR SHALL OBTAIN SHOP DRAWING APPROVAL PRIOR TO ORDERING STREET LIGHTS.
2. ALL STREET LIGHT POLES, ARMS AND HARDWARE SHALL BE HOT-DIPPED GALVANIZED. POLES, ARMS AND HARDWARE SHALL BE FREE OF WHITE RUST.
3. ALL STREET LIGHT BASES SHALL BE POURED IN PLACE.
4. TOP OF POLE DEFLECTION WITH ARM AND LUMINAIRE SHALL BE MAXIMUM 4 DEGREES FROM VERTICAL (SEE BELOW)

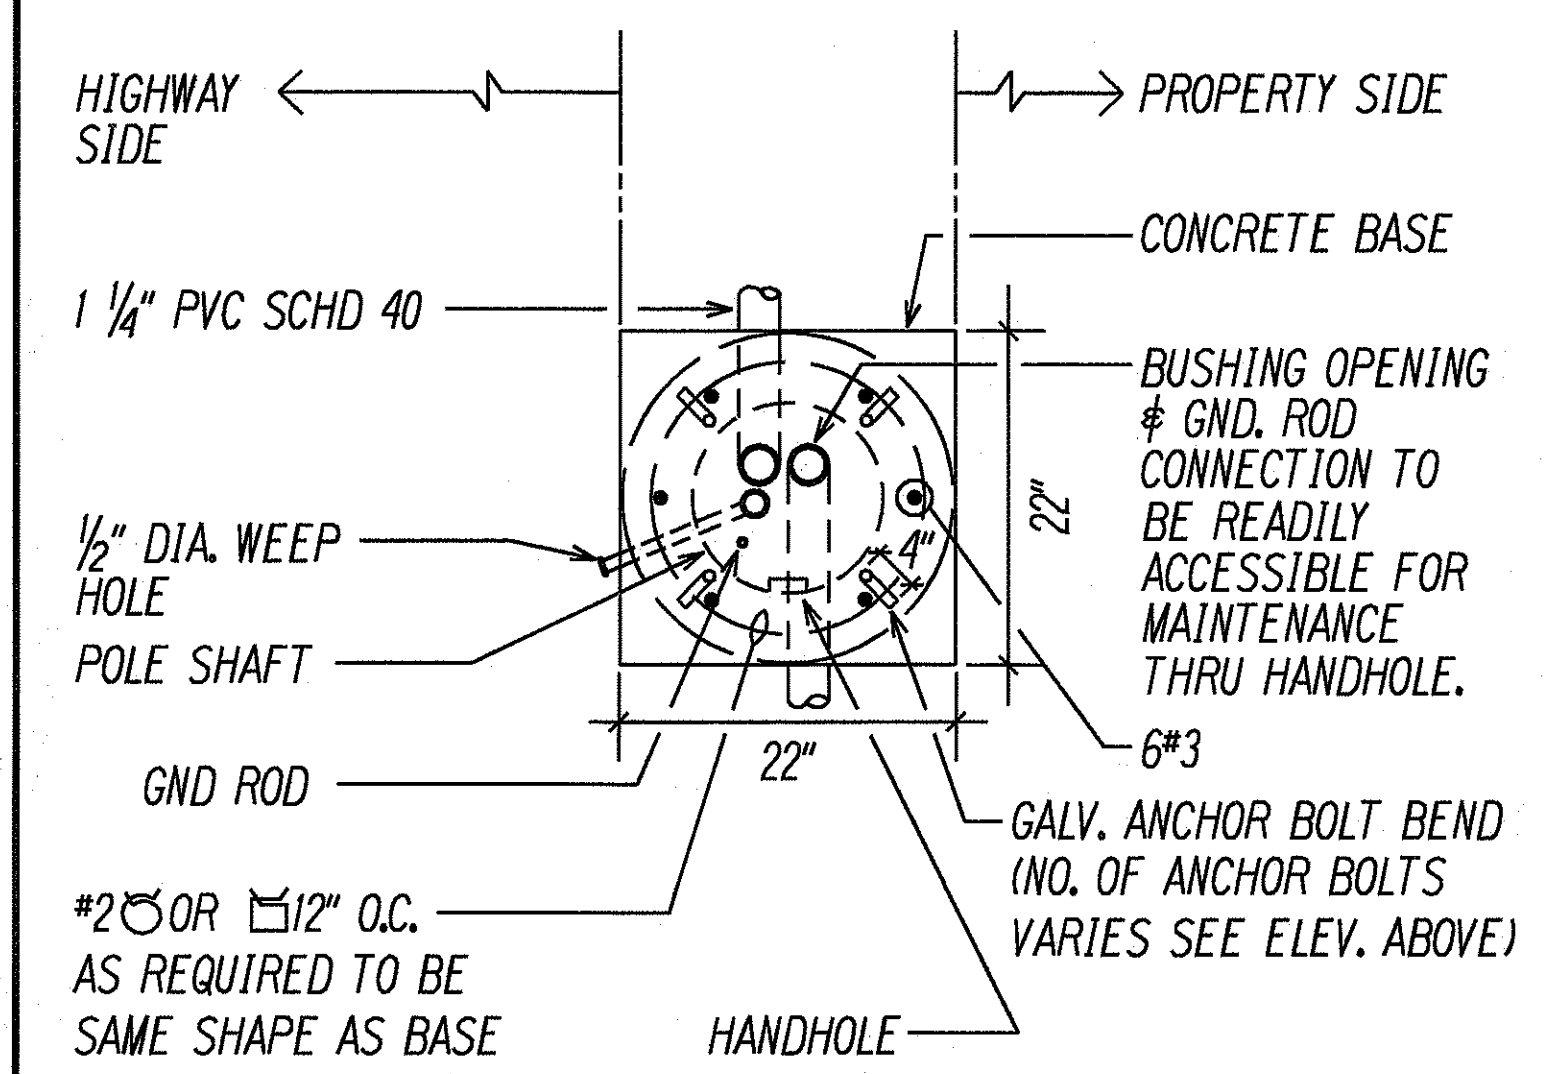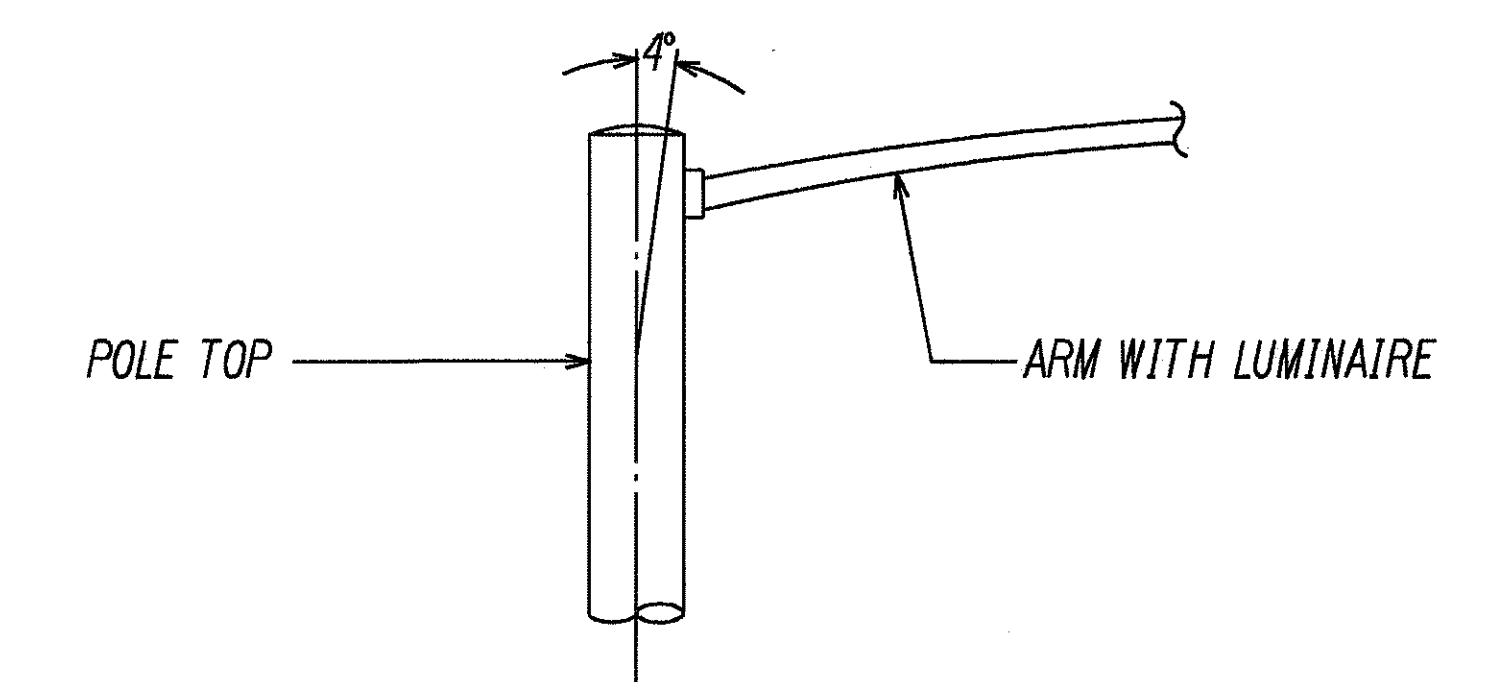

C
E28/E28 CONCRETE BASE PLAN
NOT TO SCALE

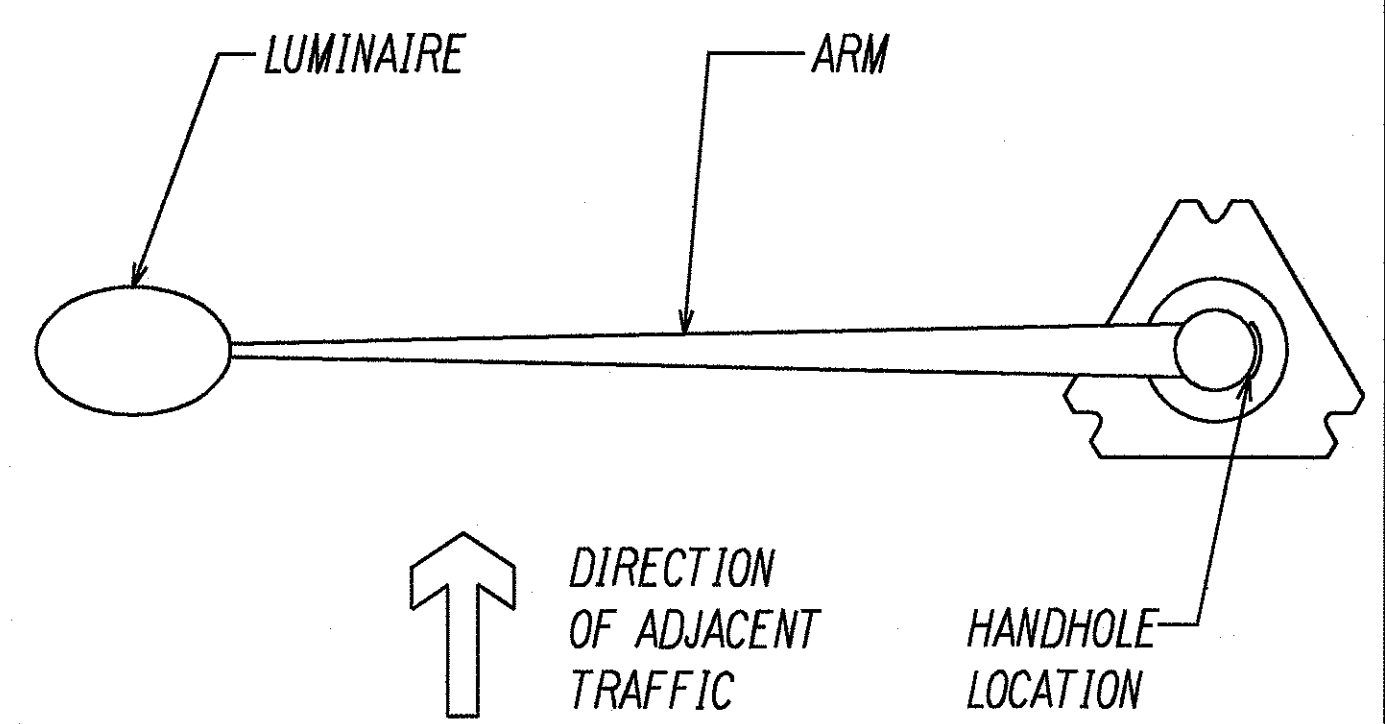


D
E26/E28 SLIP BASE-ARM
E27 ORIENTATION DETAIL

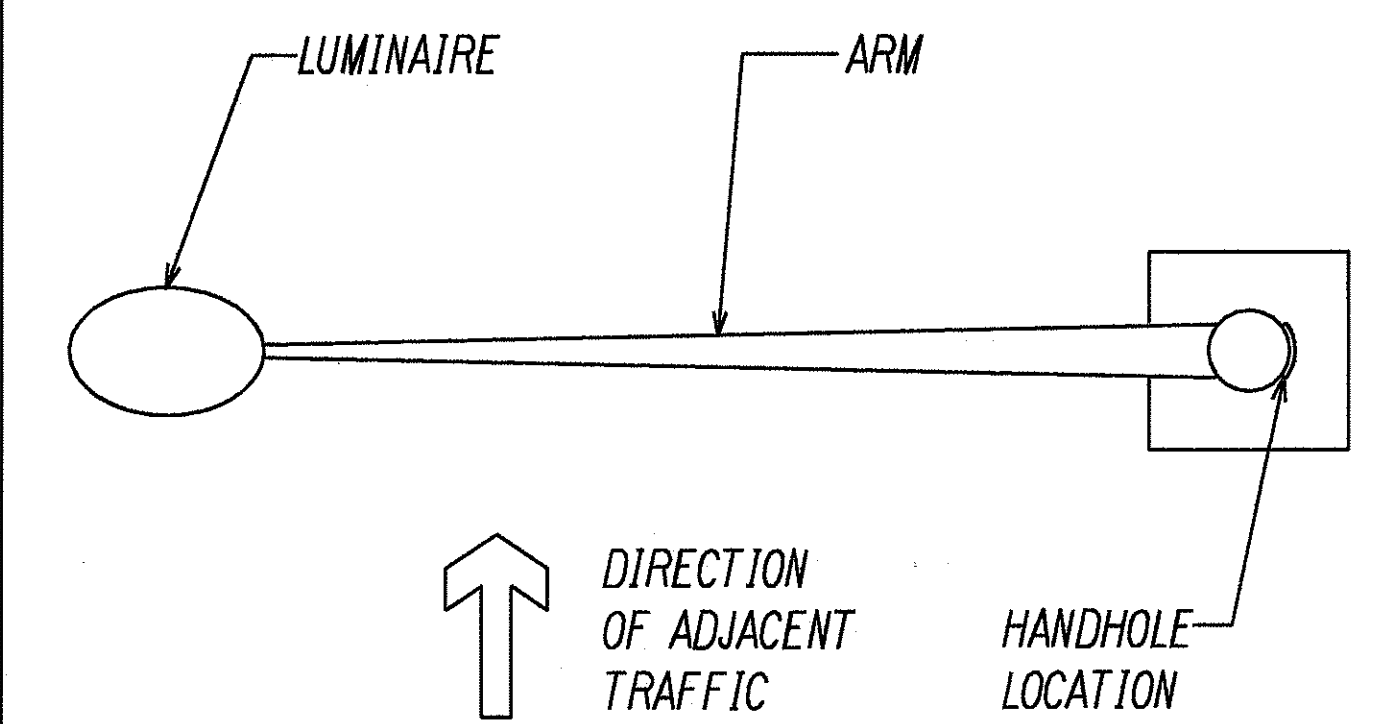

E
E26/E28 ANCHOR BASE-ARM
ORIENTATION DETAIL

DATE	
SURVEY PLOTTED BY	
DRAWN BY	
TRACED BY	
NOTE BOOK	
CHECKED BY	

LAST SHG. 6/10/98 & 6/10/98 BY G. F. PUT. 249
© 2000 PROJECTS 8888/0000/0000

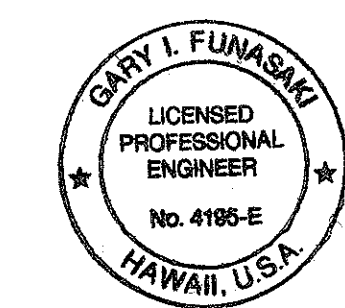

THIS WORK WAS PREPARED BY ME OR UNDER MY SUPERVISION.
[Signature]
6 Nov 1997


STATE OF HAWAII
DEPARTMENT OF TRANSPORTATION
HIGHWAYS DIVISION

CONCRETE BASE AND STREET LIGHT DETAILS


INTERSTATE ROUTE H-1
Kunia Interchange Improvements
F.A.I. Project No 1M-HI-1(219)

SCALE: AS NOTED DATE: OCT. 1997
SHEET No. E28 OF E43 SHEETS

FED. ROAD DIST. NO.	STATE	FED. AID PROJ. NO.	FISCAL YEAR	SHEET NO.	TOTAL SHEETS
HAWAII	HAW.	1M-HI-1(219)	1998	253	378

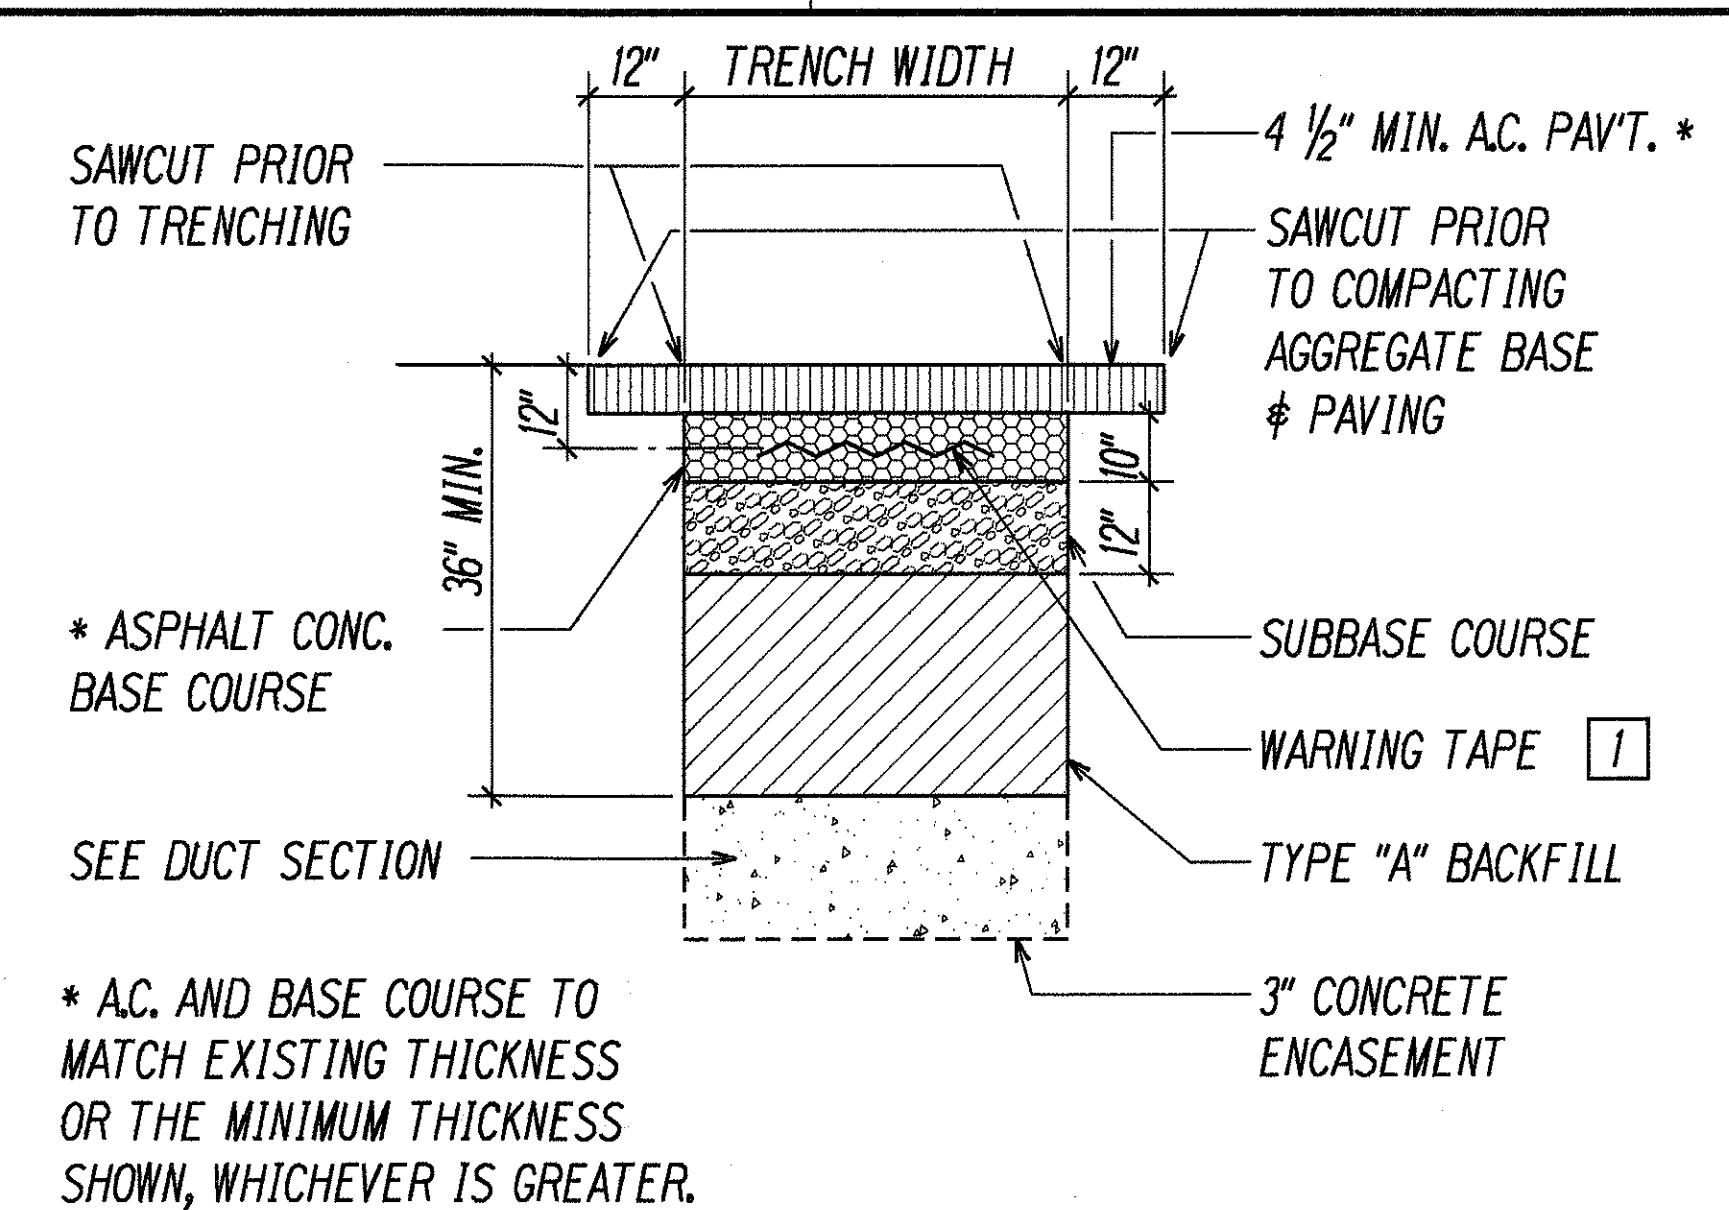

① EXCAVATION AND BACKFILL SECTION
WITHIN STATE RIGHT-OF-WAY
UNDER EXISTING ROADWAY &
PAVED SHOULDER

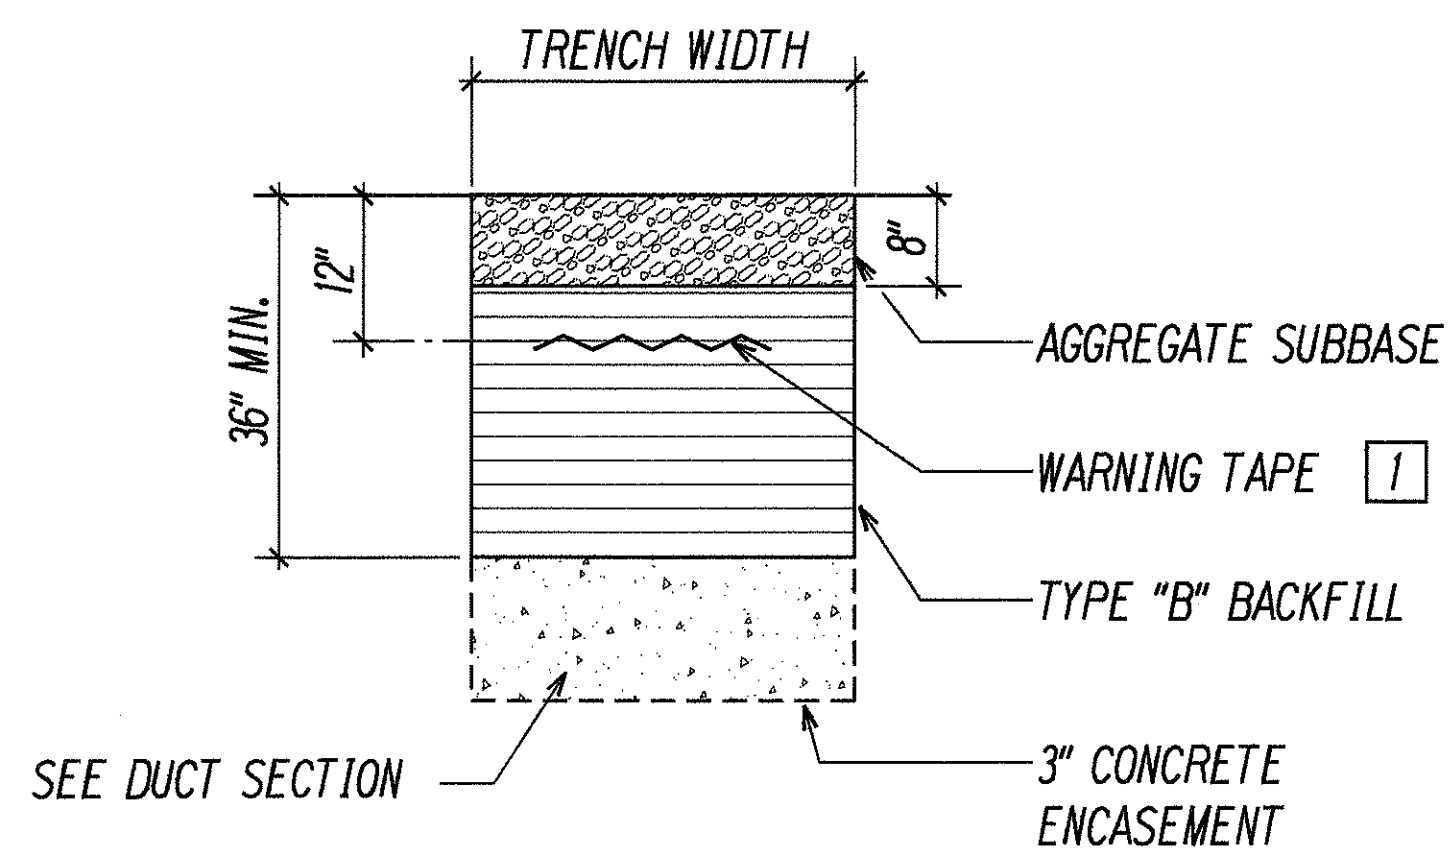

② EXCAVATION AND BACKFILL SECTION
WITHIN STATE RIGHT-OF-WAY
UNDER UNPAVED SHOULDER

STATE RIGHT-OF-WAY BACKFILL NOTES



N.T.S.

- TRENCH BACKFILL MATERIAL "B"
1. SAND EQUIVALENT ≥ 2
2. 8" MAX. LIFT LOOSE
3. 95% COMPACTION
- TRENCH BACKFILL MATERIAL "A"
1. SAND EQUIVALENT ≥ 20
2. 8" MAX. LIFT LOOSE
3. 95% COMPACTION
- IF MATERIAL BELOW DUCT IS NOT EQUIVALENT TO BACKFILL MATERIAL "A", EXCAVATE MATERIAL & PROVIDE 3" BACKFILL MATERIAL "A". SEE ABOVE
- CONCRETE - 3" ENCASEMENT, 2500 PSI COMPRESSIVE STRENGTH @ 28 DAYS.


NOTE: BASE COURSE & SUB-BASE COURSE PER 1994 STATE STANDARD SPECIFICATIONS FOR HIGHWAY CONSTRUCTION.

NOTE(S):


- 1** CONTRACTOR SHALL PLACE 8-MIL ORANGE COLORED PLASTIC WARNING TAPE, NOT LESS THAN 4" WIDE IN ENTIRE LENGTH OF TRENCH FOR ALL UNDERGROUND INSTALLATIONS.

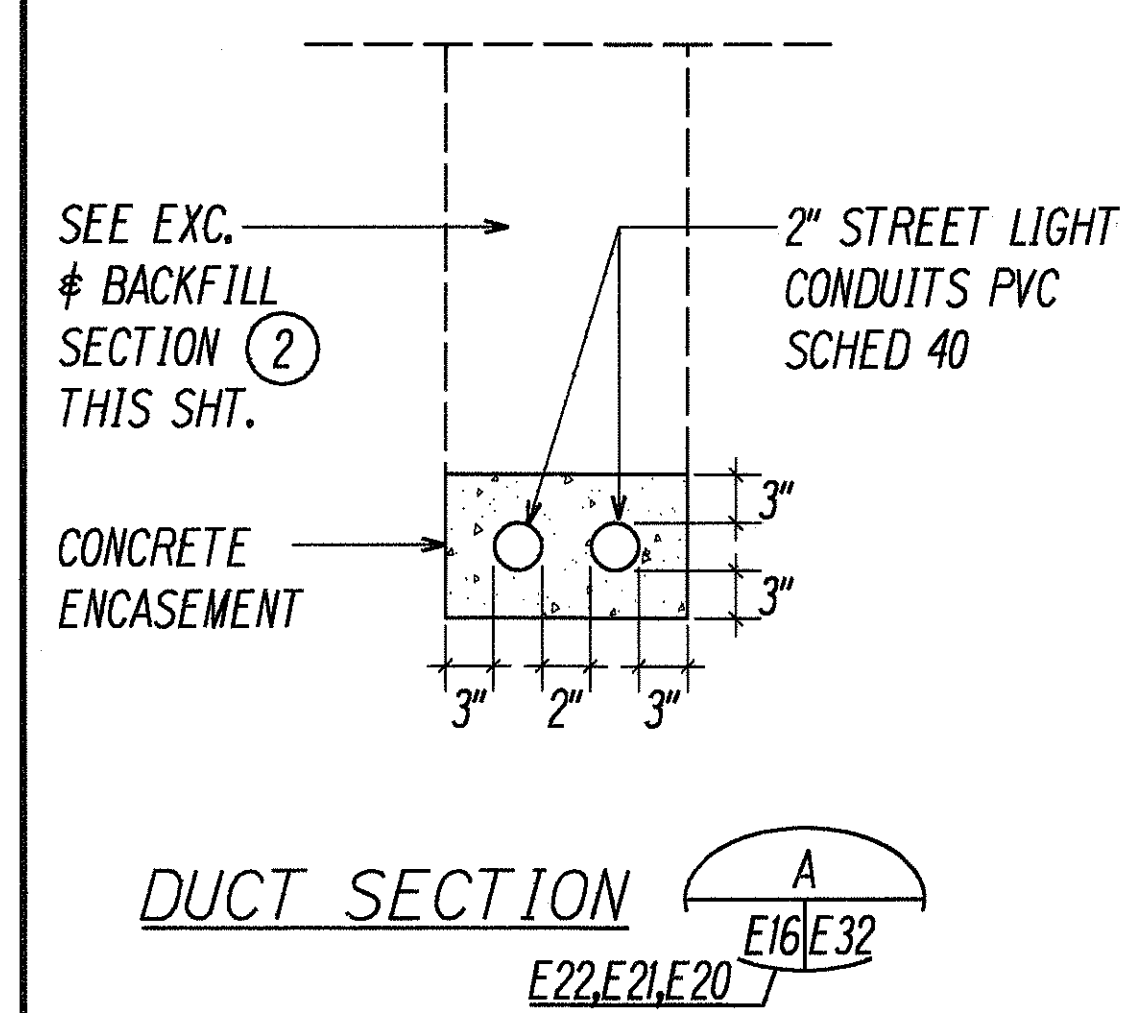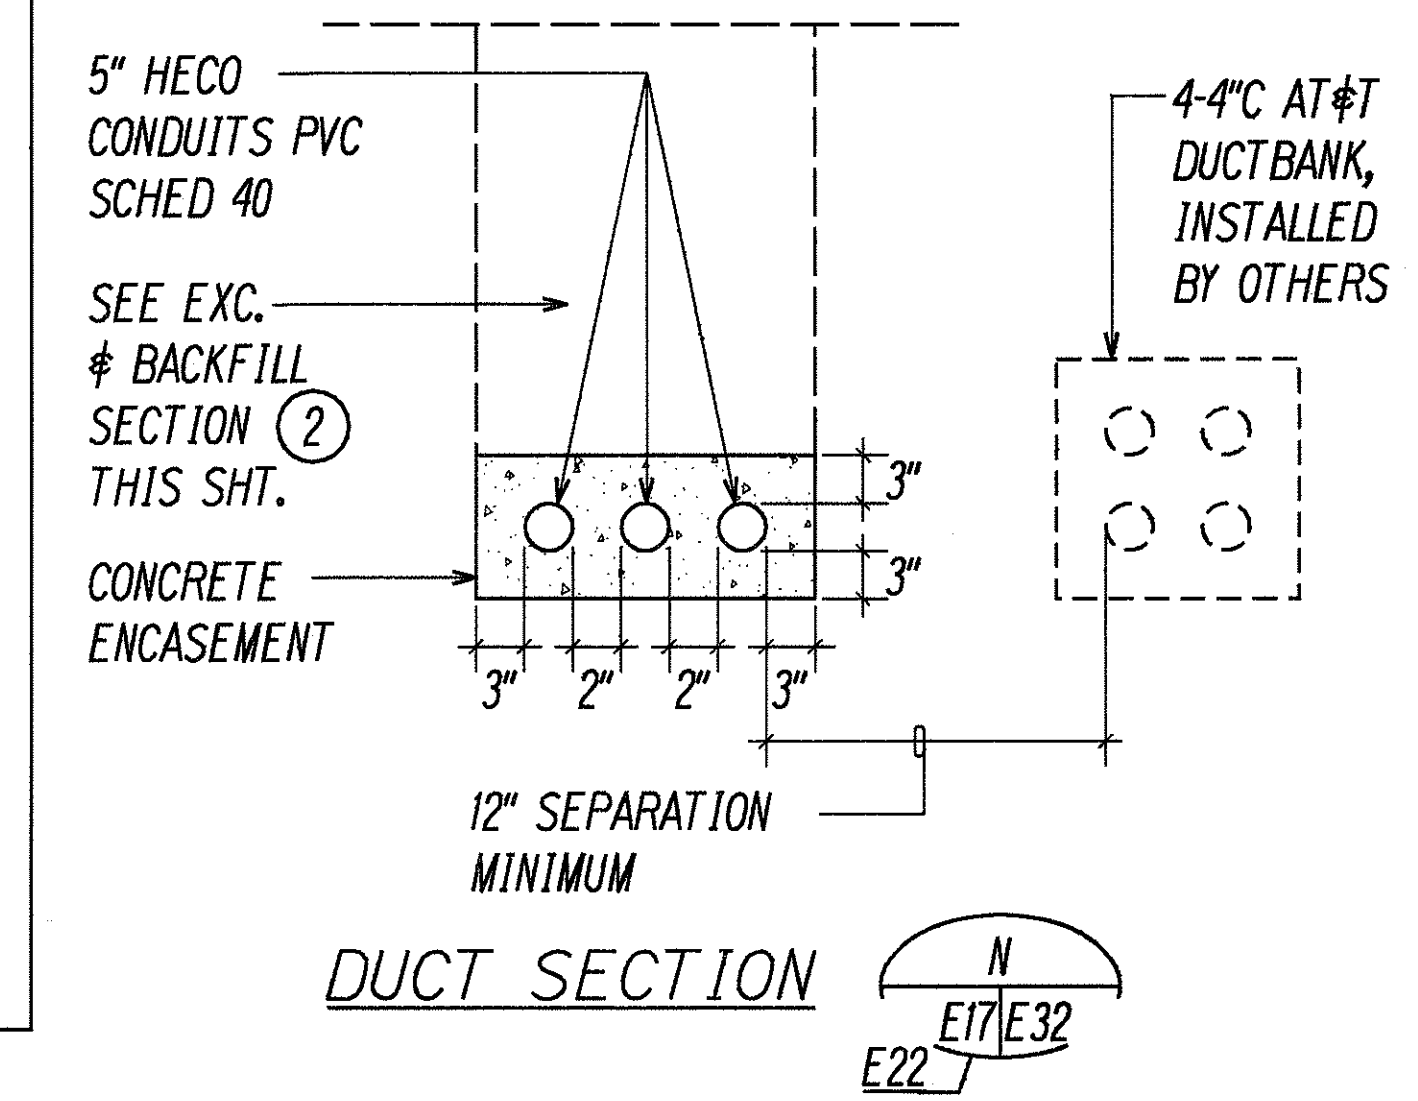


DUCT SECTION A
E22,E21,E20

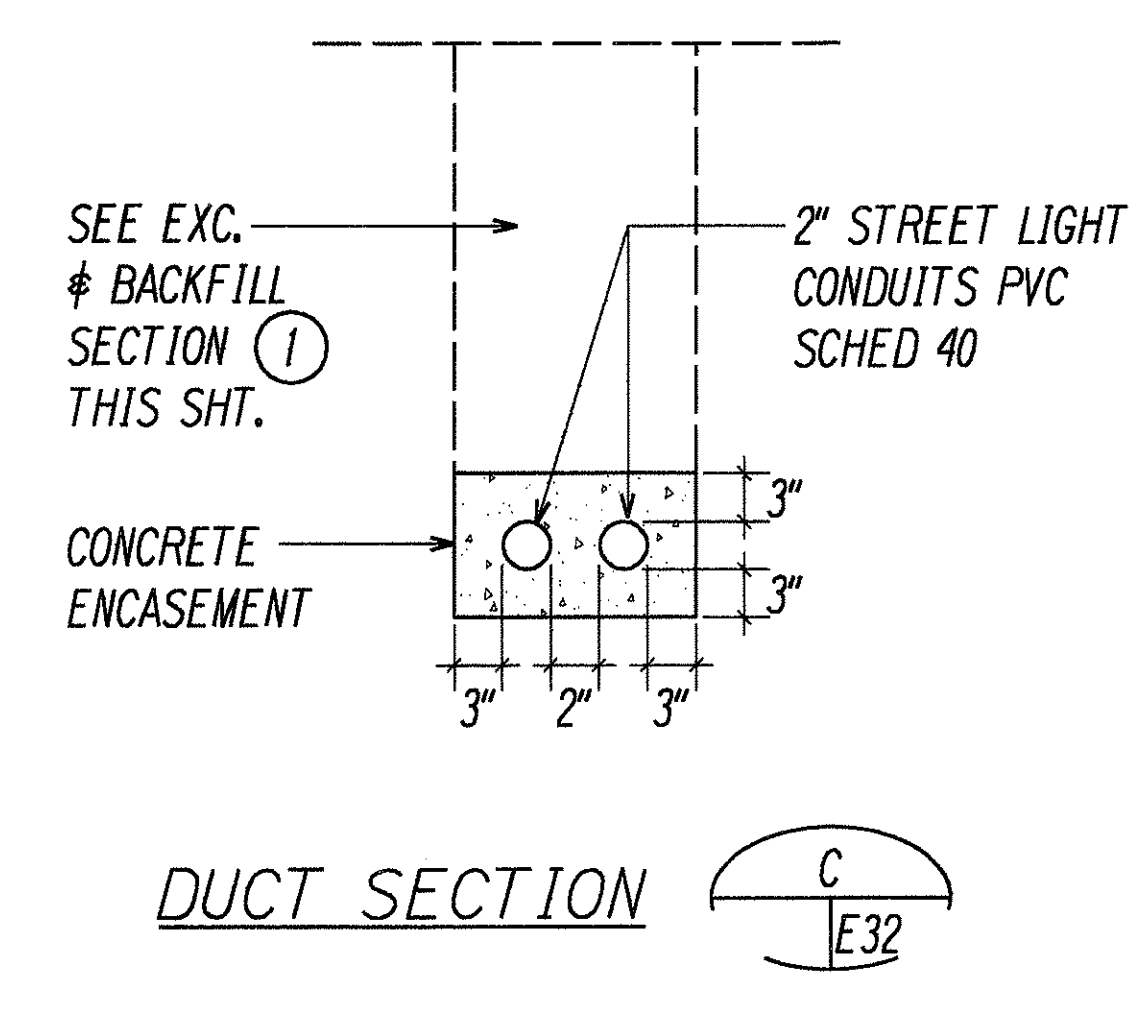


DUCT SECTION C
E32

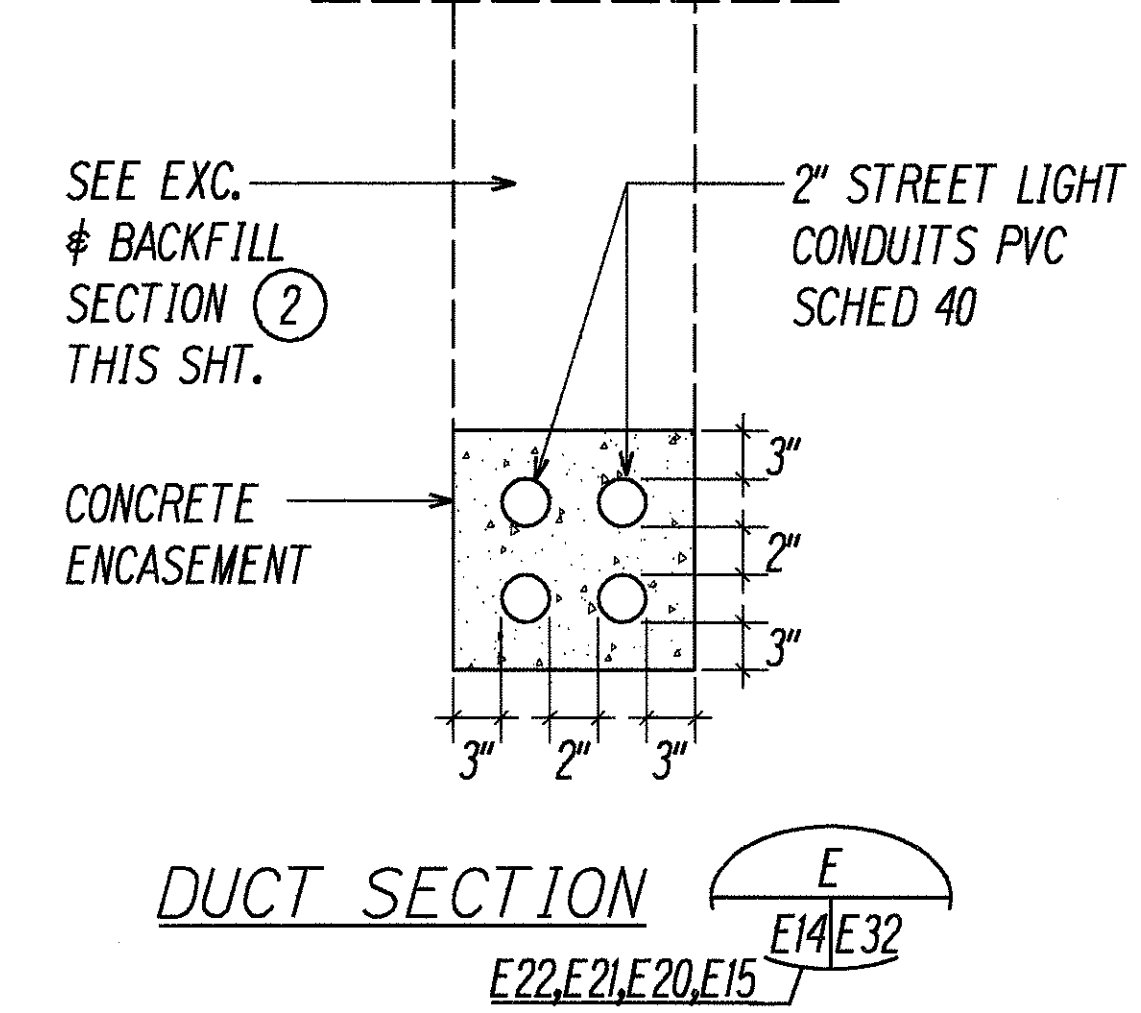


DUCT SECTION E
E22,E21,E20,E15

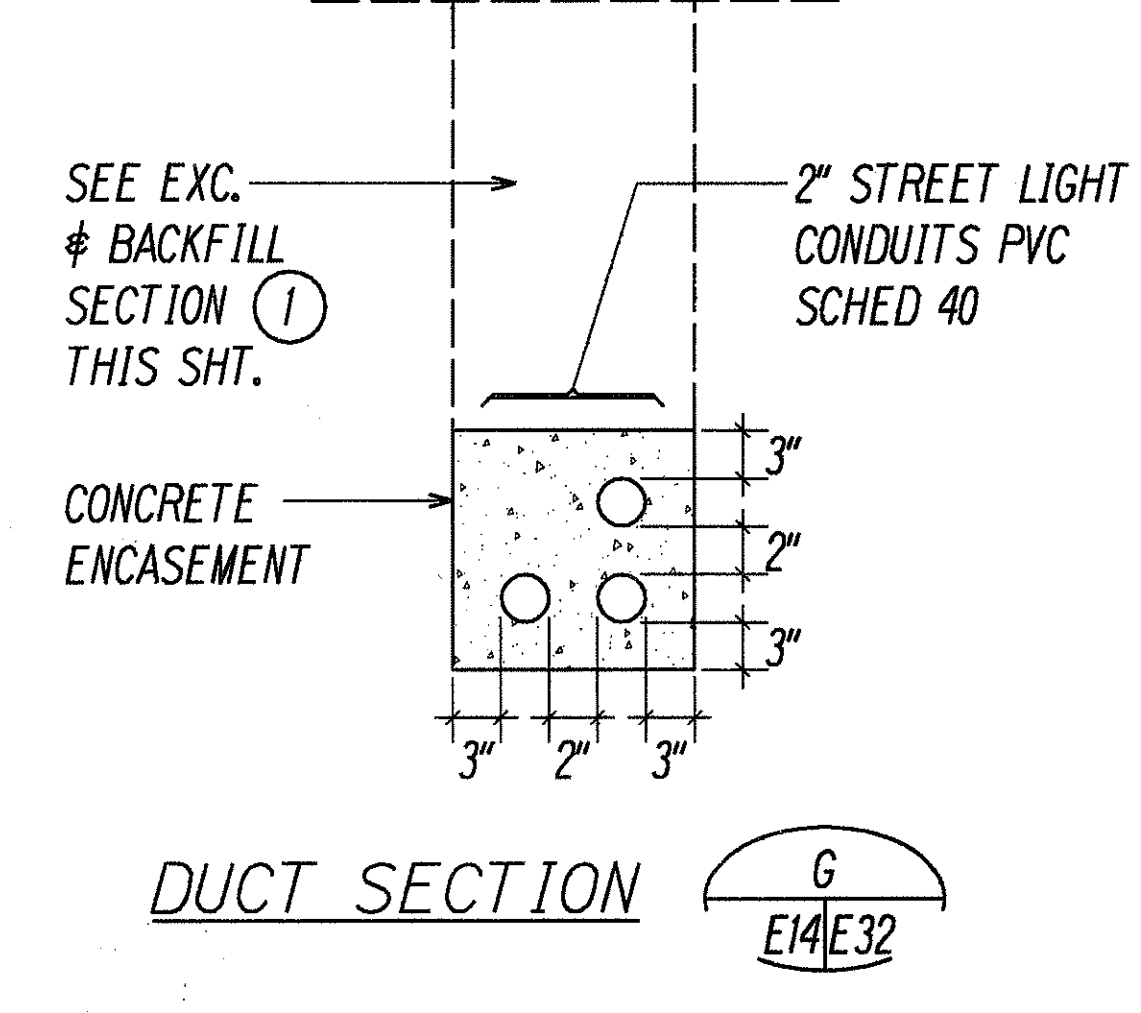


DUCT SECTION G
E14,E32

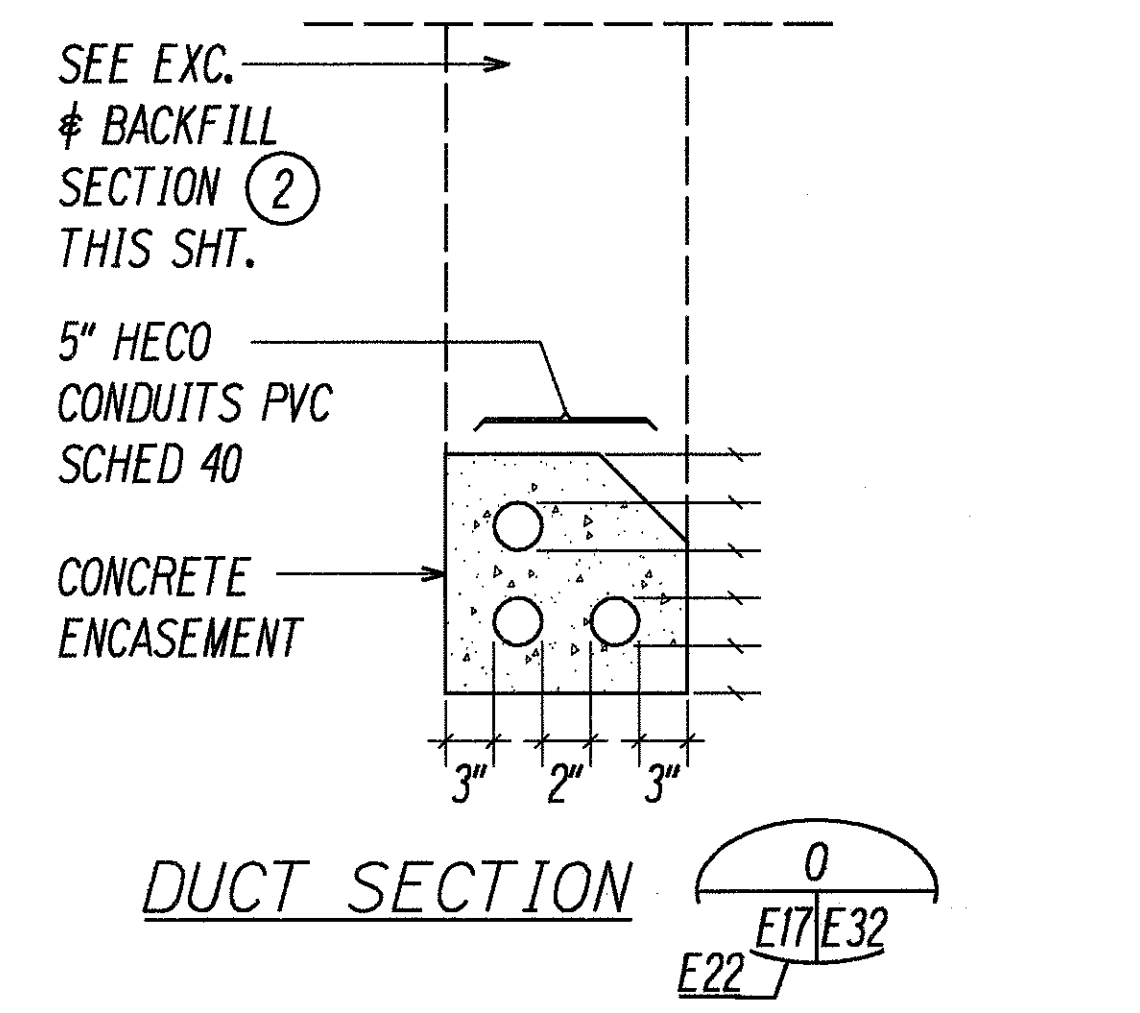


DUCT SECTION O
E17,E32

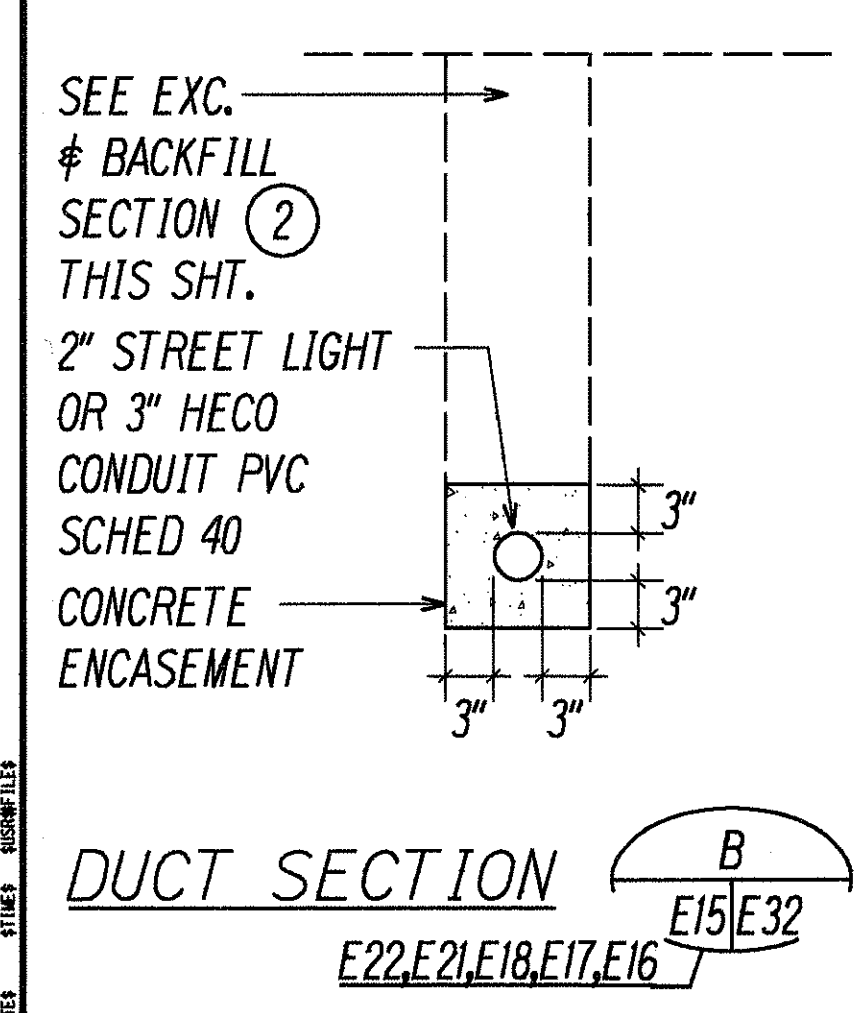


DUCT SECTION B
E22,E21,E18,E17,E16

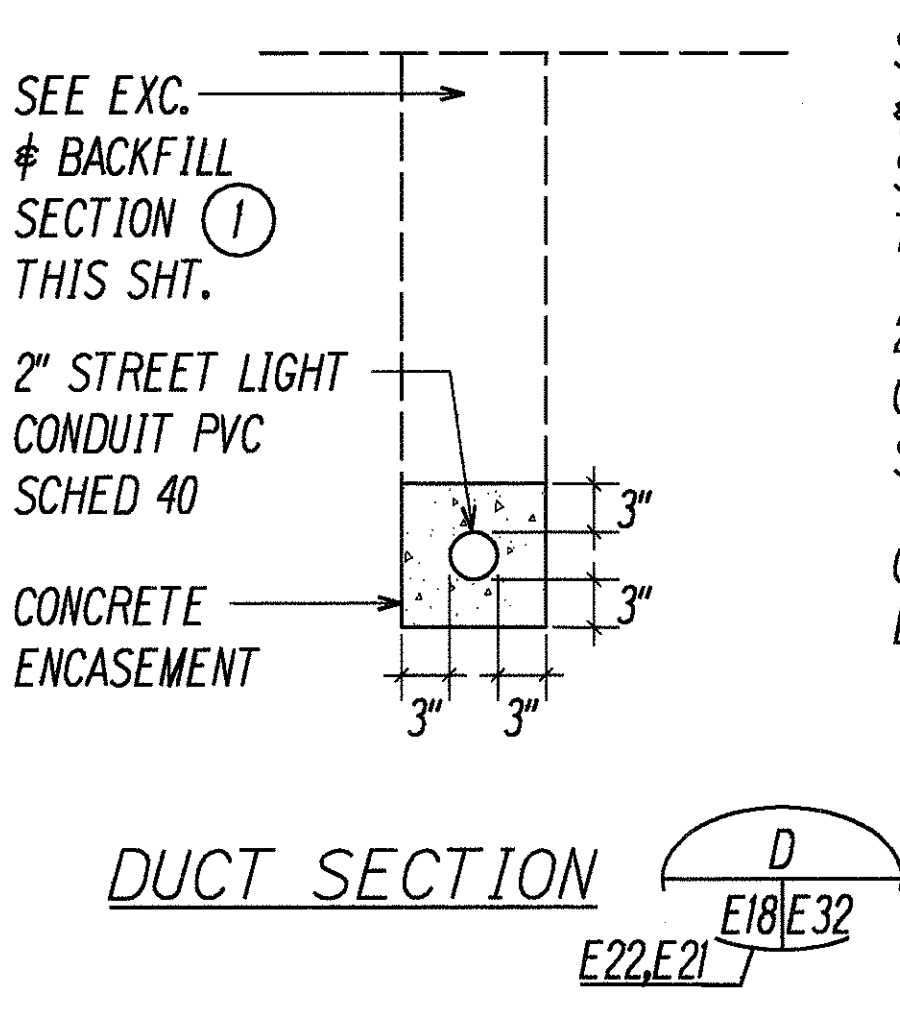


DUCT SECTION D
E18,E32

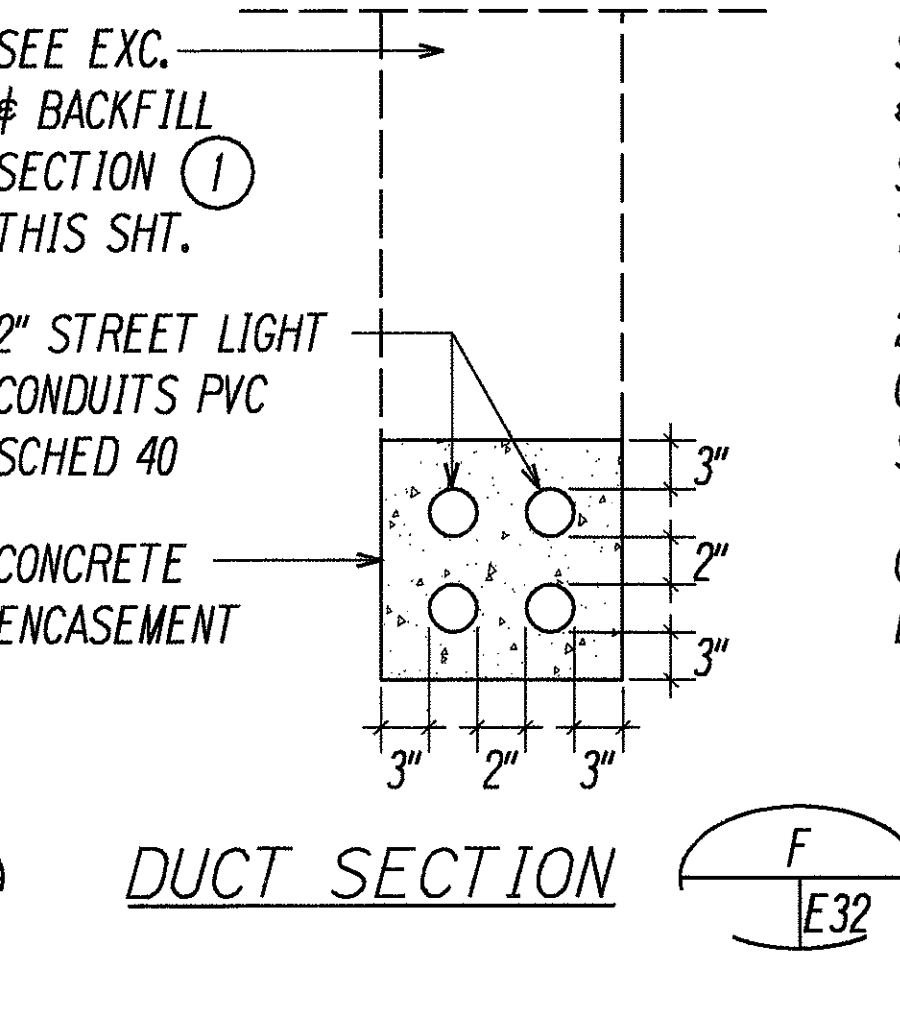

DUCT SECTION F
E32

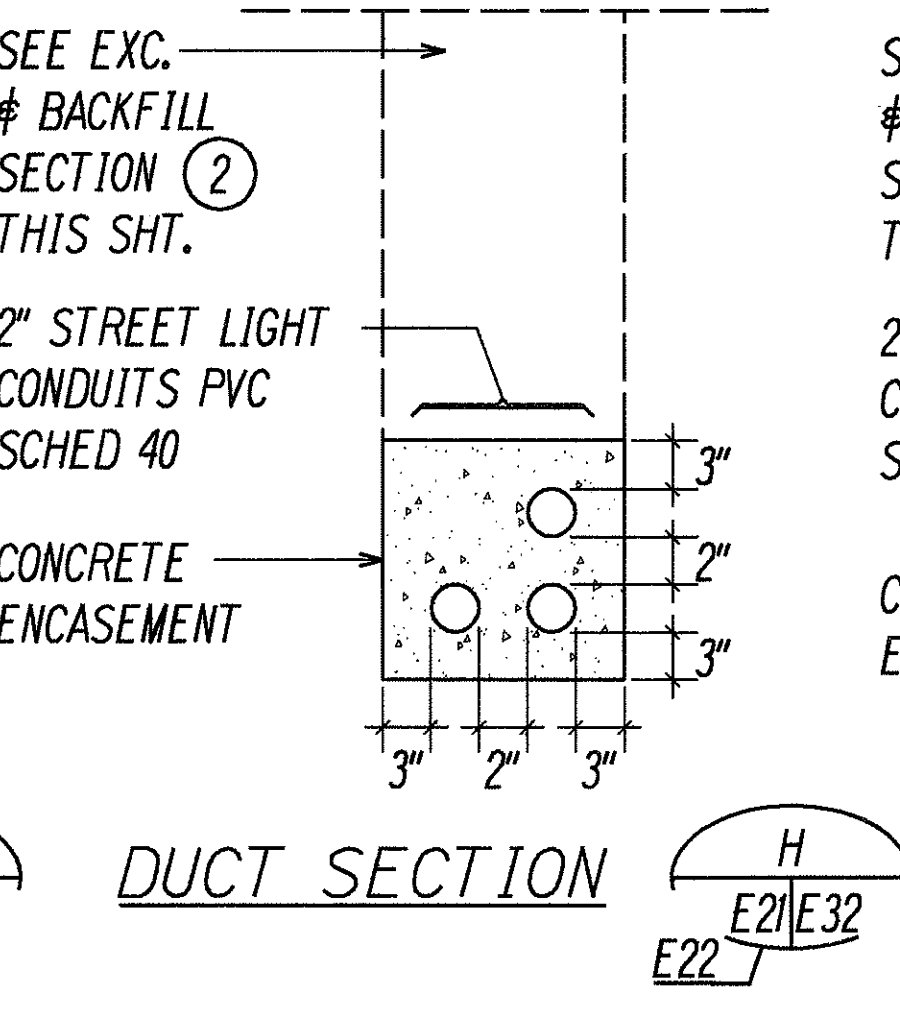


DUCT SECTION H
E21,E32

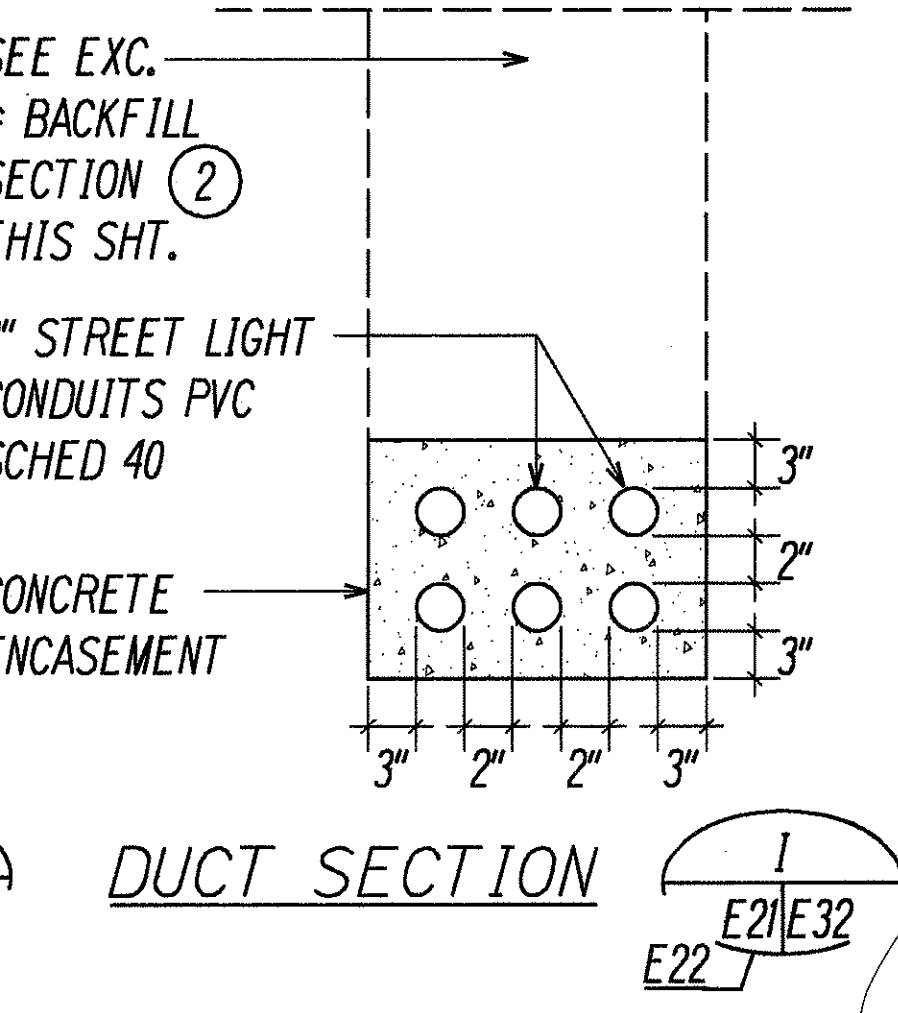

DUCT SECTION I
E21,E32

SURVEY PLOTTED BY	DATE
DRAWN BY	
DESIGNED BY	
CHECKED BY	
ORIGINAL PLAN	
NOTE BOOK	
NO.	


LAST DATE: 04/09/99
DRAWN BY: 174
DESIGNED BY: 174
CHECKED BY: 174
NO. 174
DATE: 04/09/99

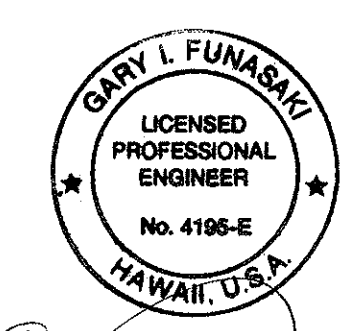


THIS WORK WAS PREPARED BY ME OR UNDER MY SUPERVISION.

4/9/99	ADDED DUCT SECTION "N" & "O" DETAIL
DATE	REVISION
STATE OF HAWAII DEPARTMENT OF TRANSPORTATION HIGHWAYS DIVISION DUCT SECTIONS INTERSTATE ROUTE H-1 Kunia Interchange Improvements F.A.I. Project No. 1M-HI-1(219) SCALE: AS NOTED SHEET No. E32 OF 43 SHEETS DATE: OCT. 1997	


FED. ROAD DIST. NO.	STATE	FED. AID PROJ. NO.	FISCAL YEAR	SHEET NO.	TOTAL SHEETS
HAWAII	HAW.	1M-H1-1(219)	1998	254	378

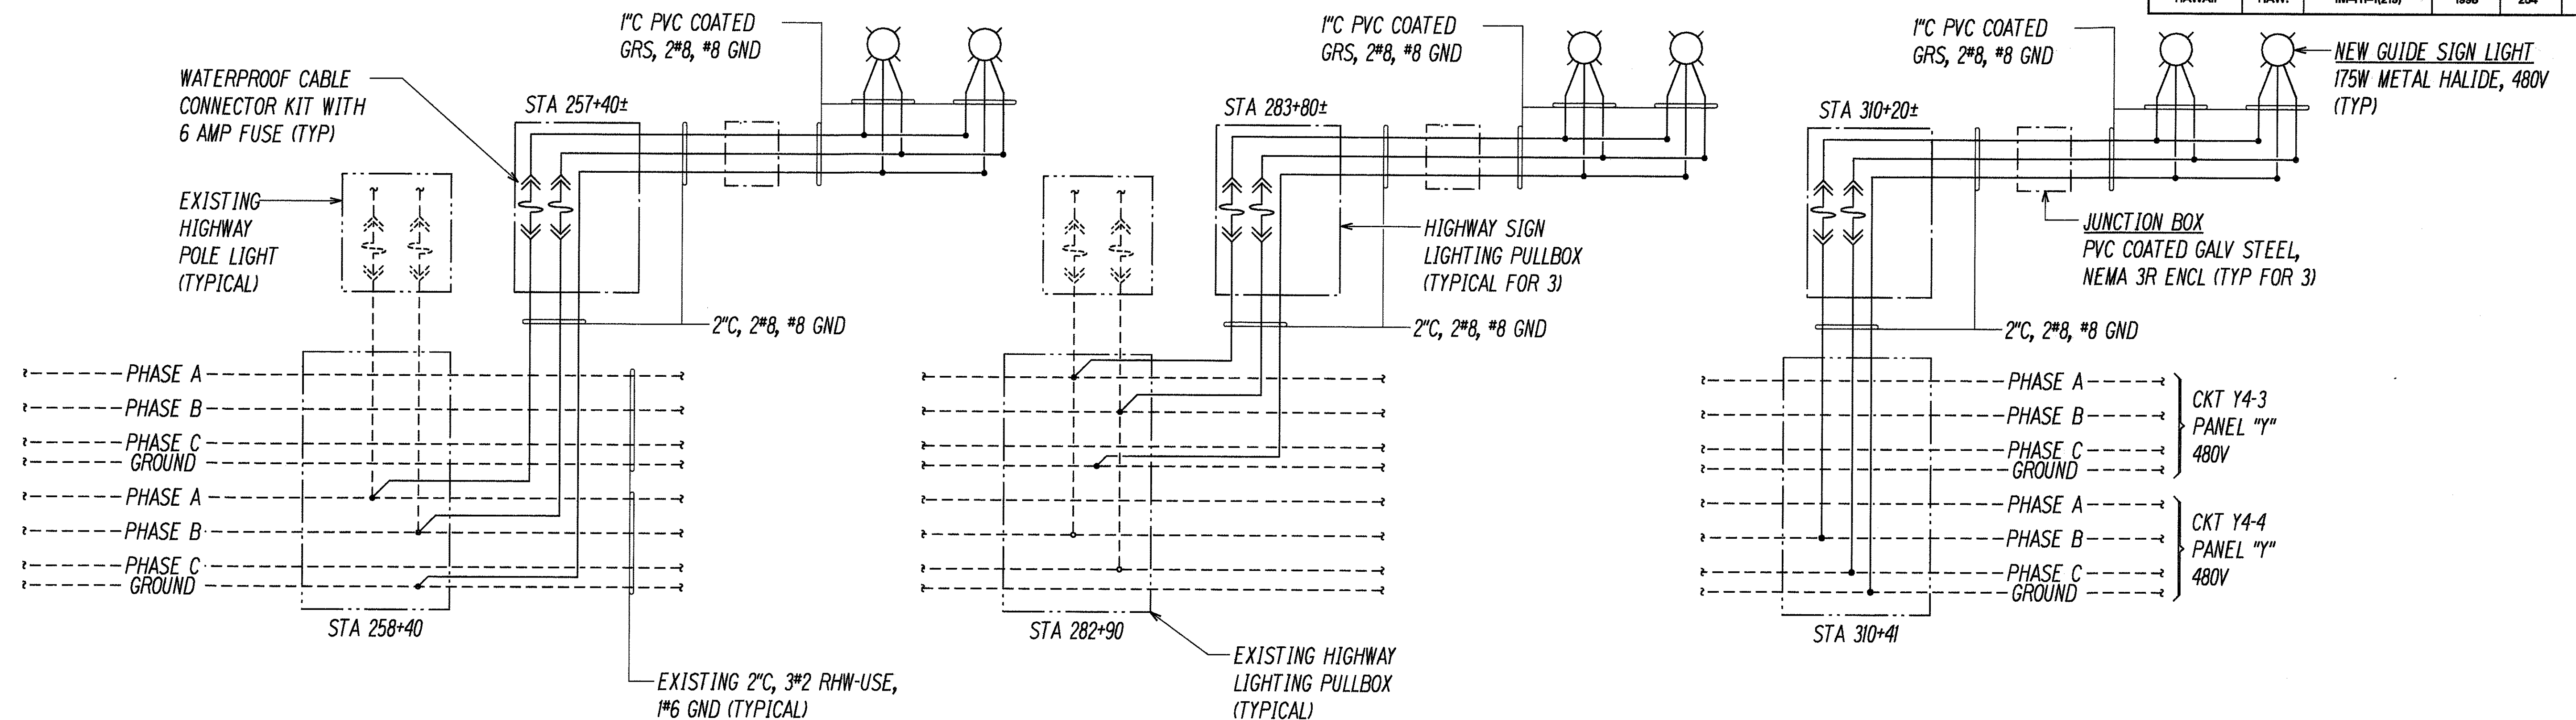


A
E14/E33
E15
HIGHWAY SIGN LIGHTING WIRING DIAGRAM I

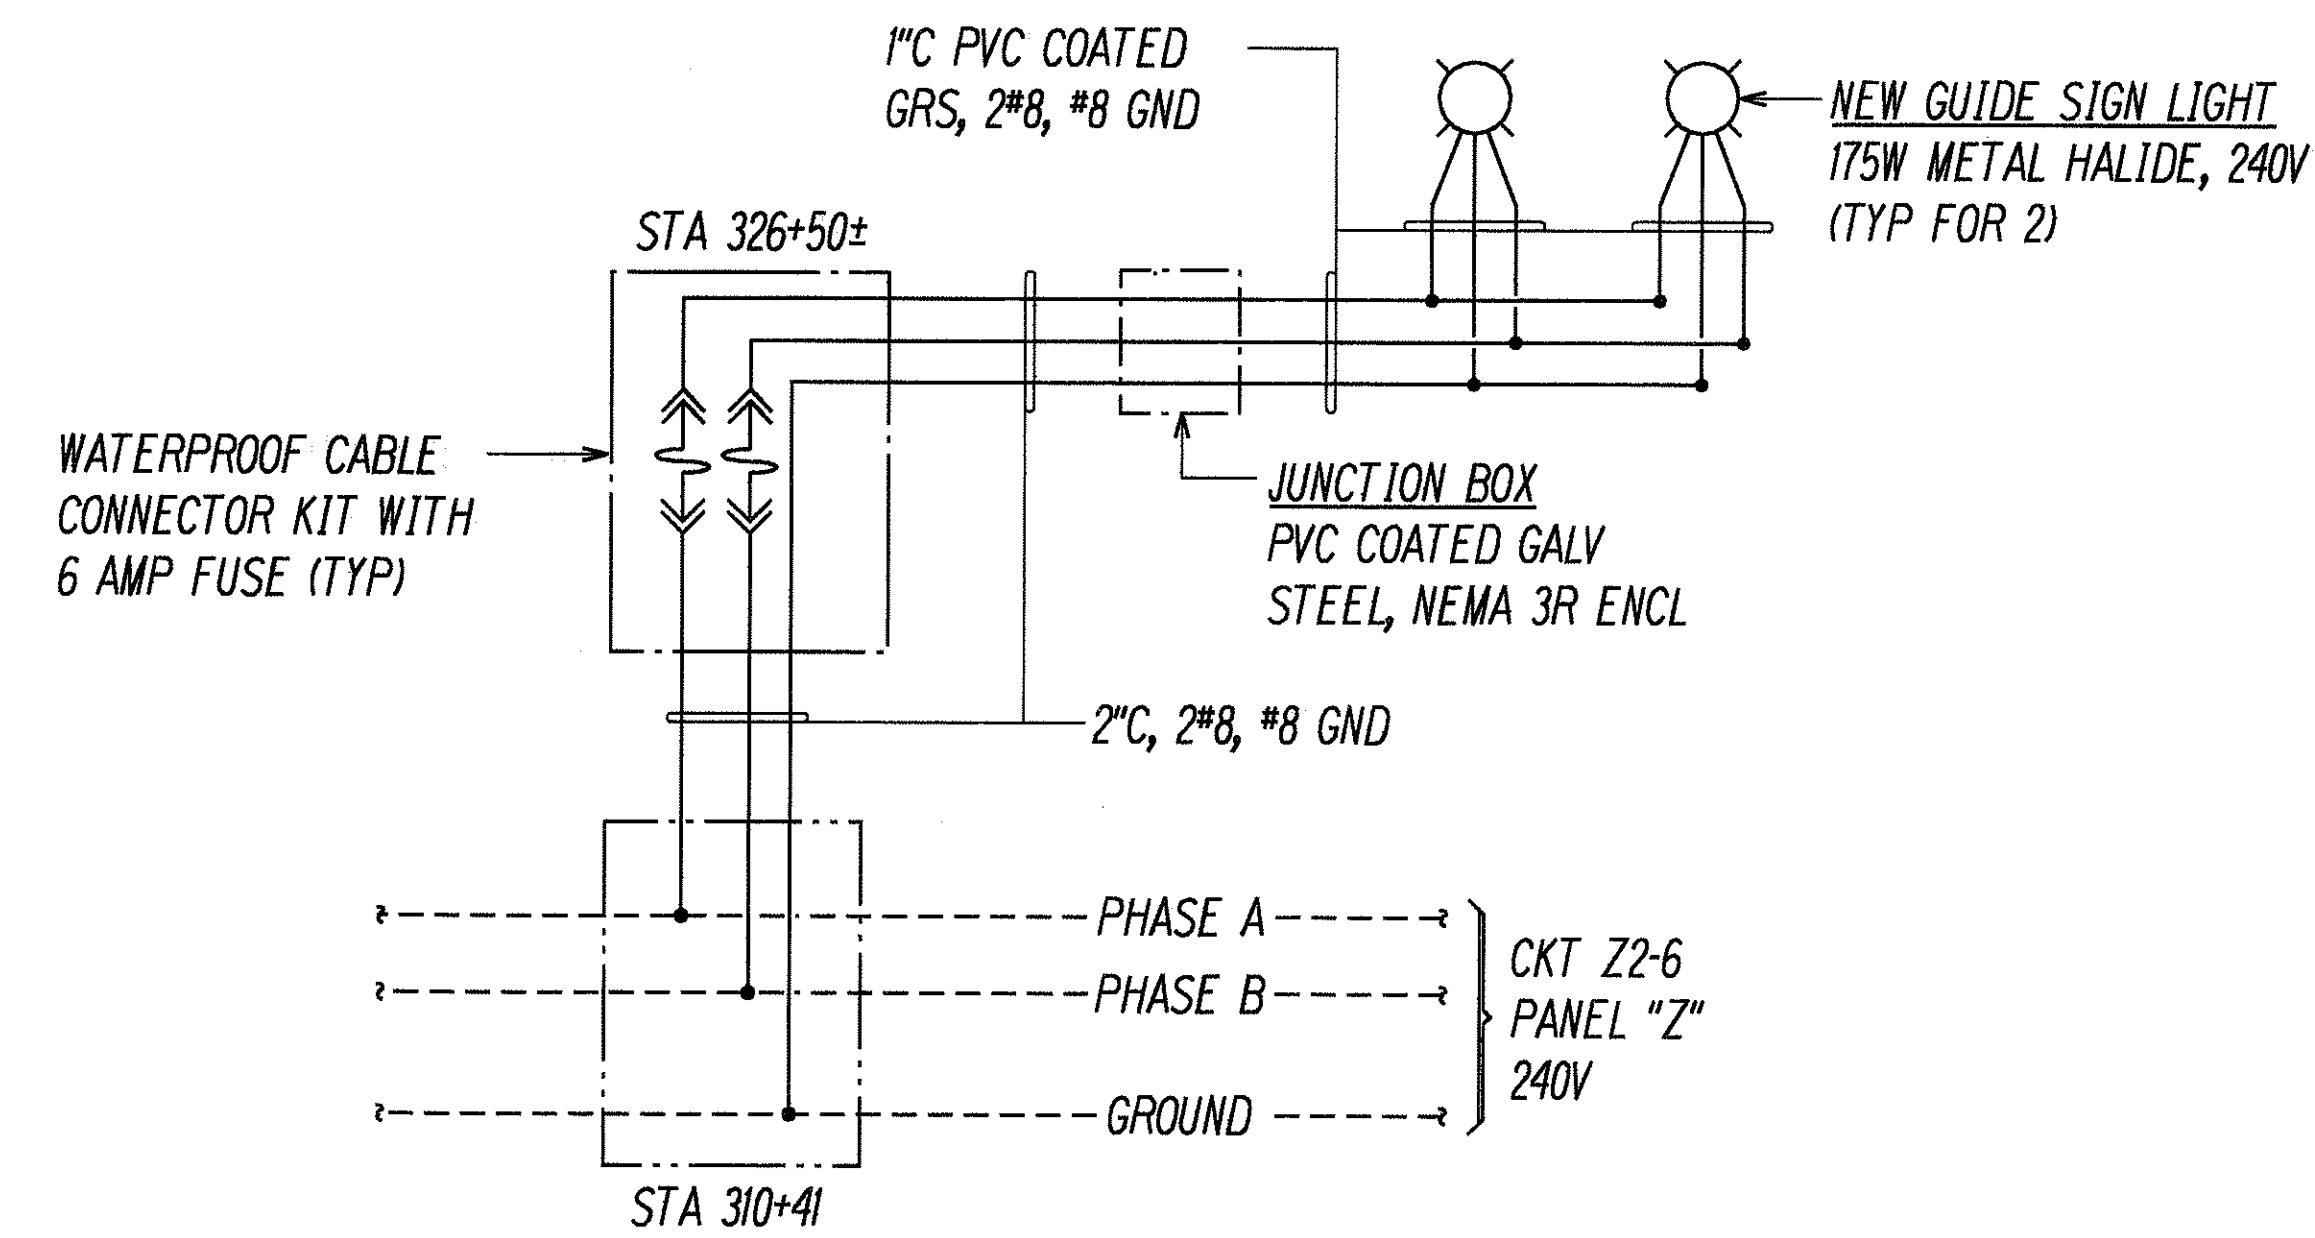

B
E17/E33
HIGHWAY SIGN LIGHTING WIRING DIAGRAM II

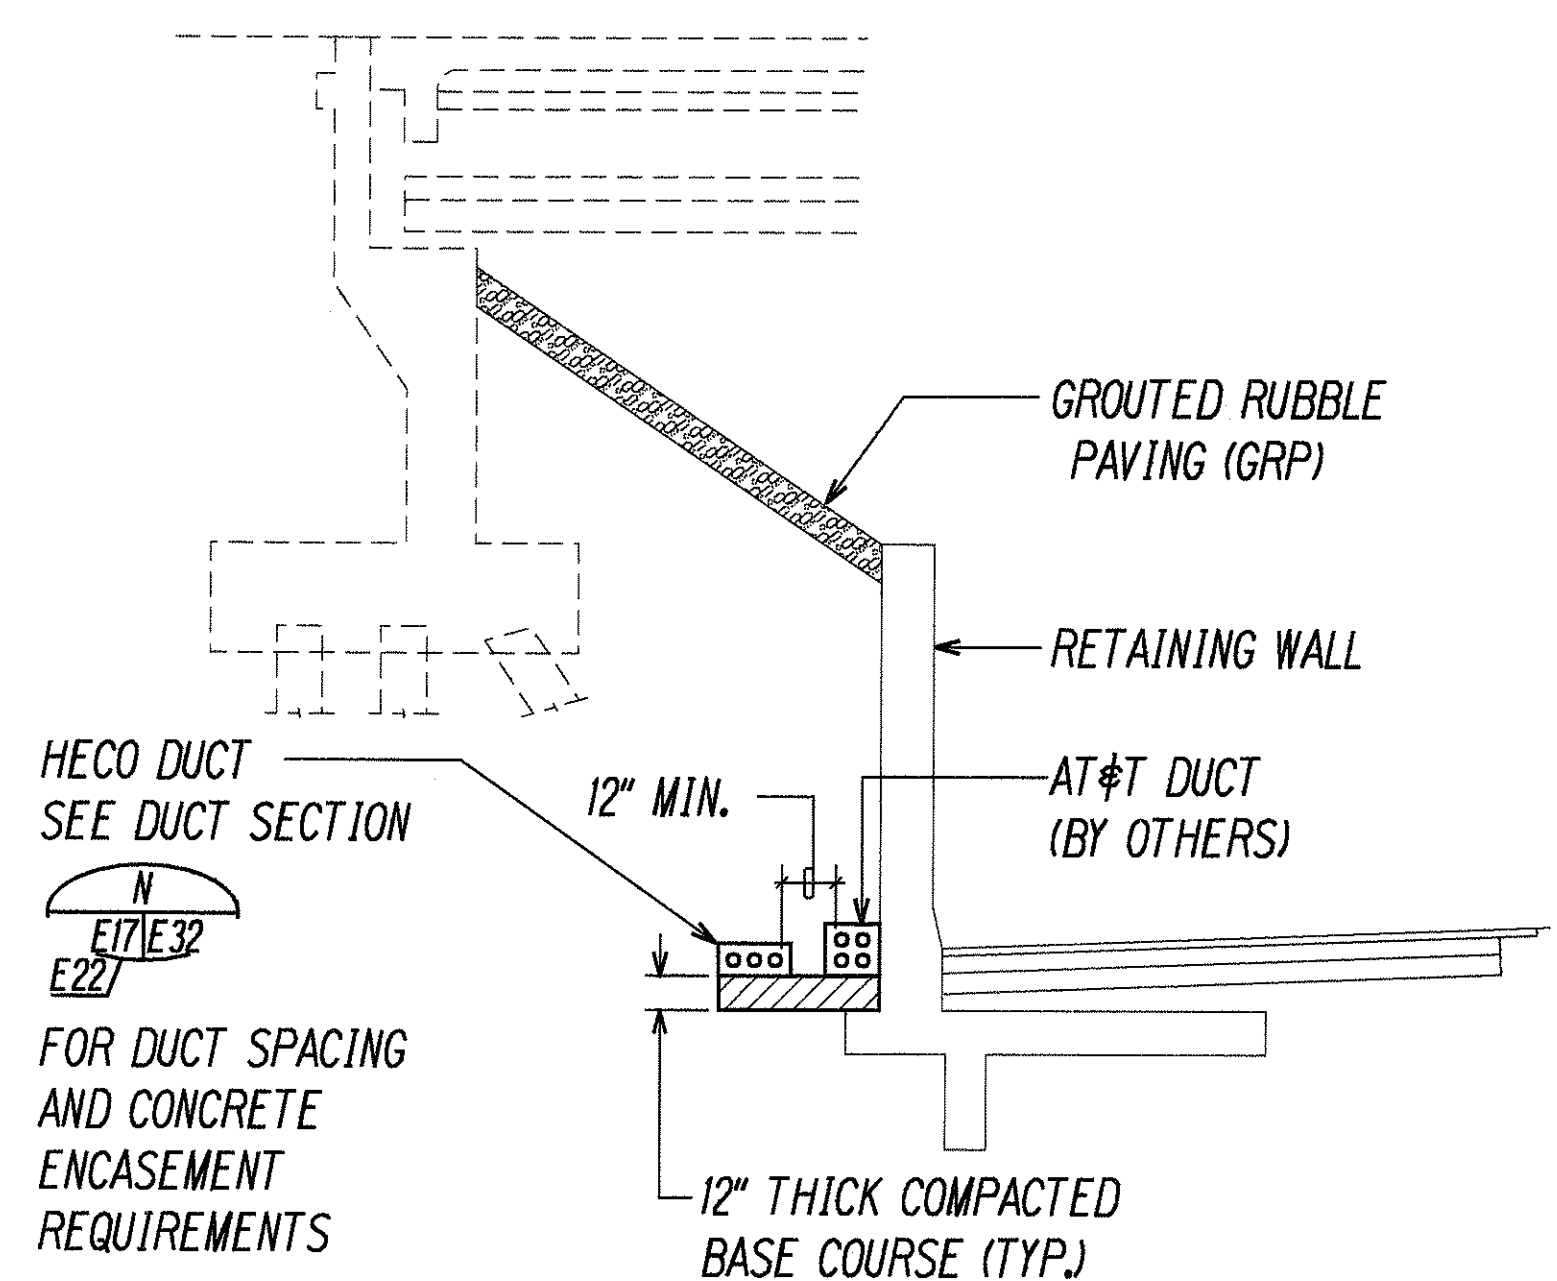



C
E17/E33
TYPICAL DUCT SECTION
BEHIND RETAINING WALL
NOT TO SCALE

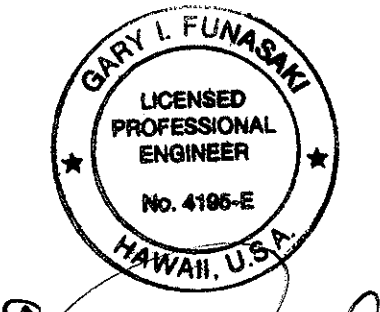


THIS WORK WAS PREPARED BY ME
OR UNDER MY SUPERVISION.

4/9/99	ADDED TYPICAL DUCT SECTION BEHIND RETAINING WALL DETAIL
DATE	REVISION
STATE OF HAWAII DEPARTMENT OF TRANSPORTATION HIGHWAYS DIVISION	
SIGN WIRING DIAGRAM	
INTERSTATE ROUTE H-1 Kunia Interchange Improvements F.A.I. Project No. 1M-H1-1(219)	
SCALE: AS NOTED	DATE: OCT. 1997
SHEET No. E33	OF 43 SHEETS


FED. ROAD DIST. NO.	STATE	FED. AID PROJ. NO.	FISCAL YEAR	SHEET NO.	TOTAL SHEETS
HAWAII	HAW.	1M-HI-K219	1998	258	378

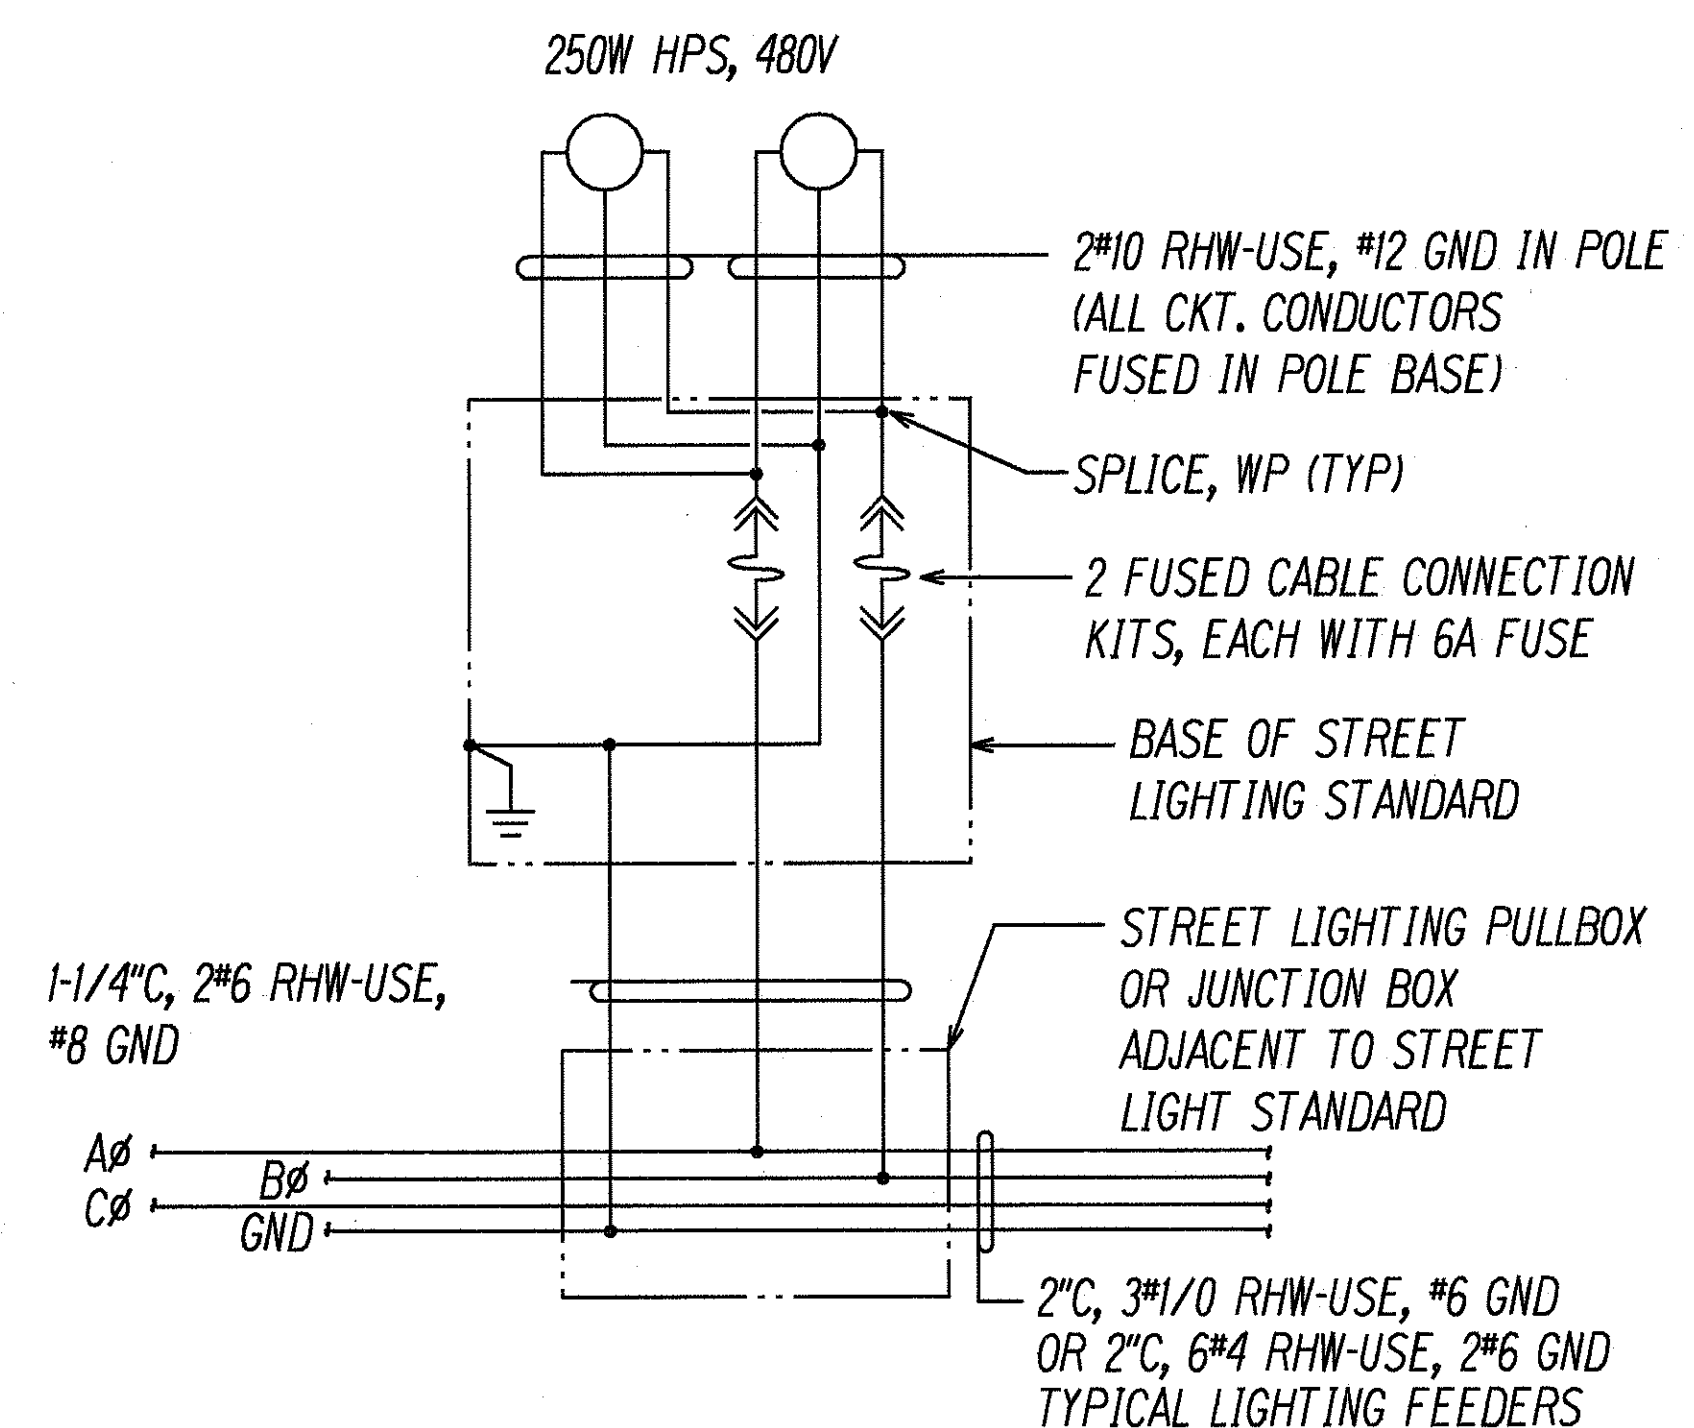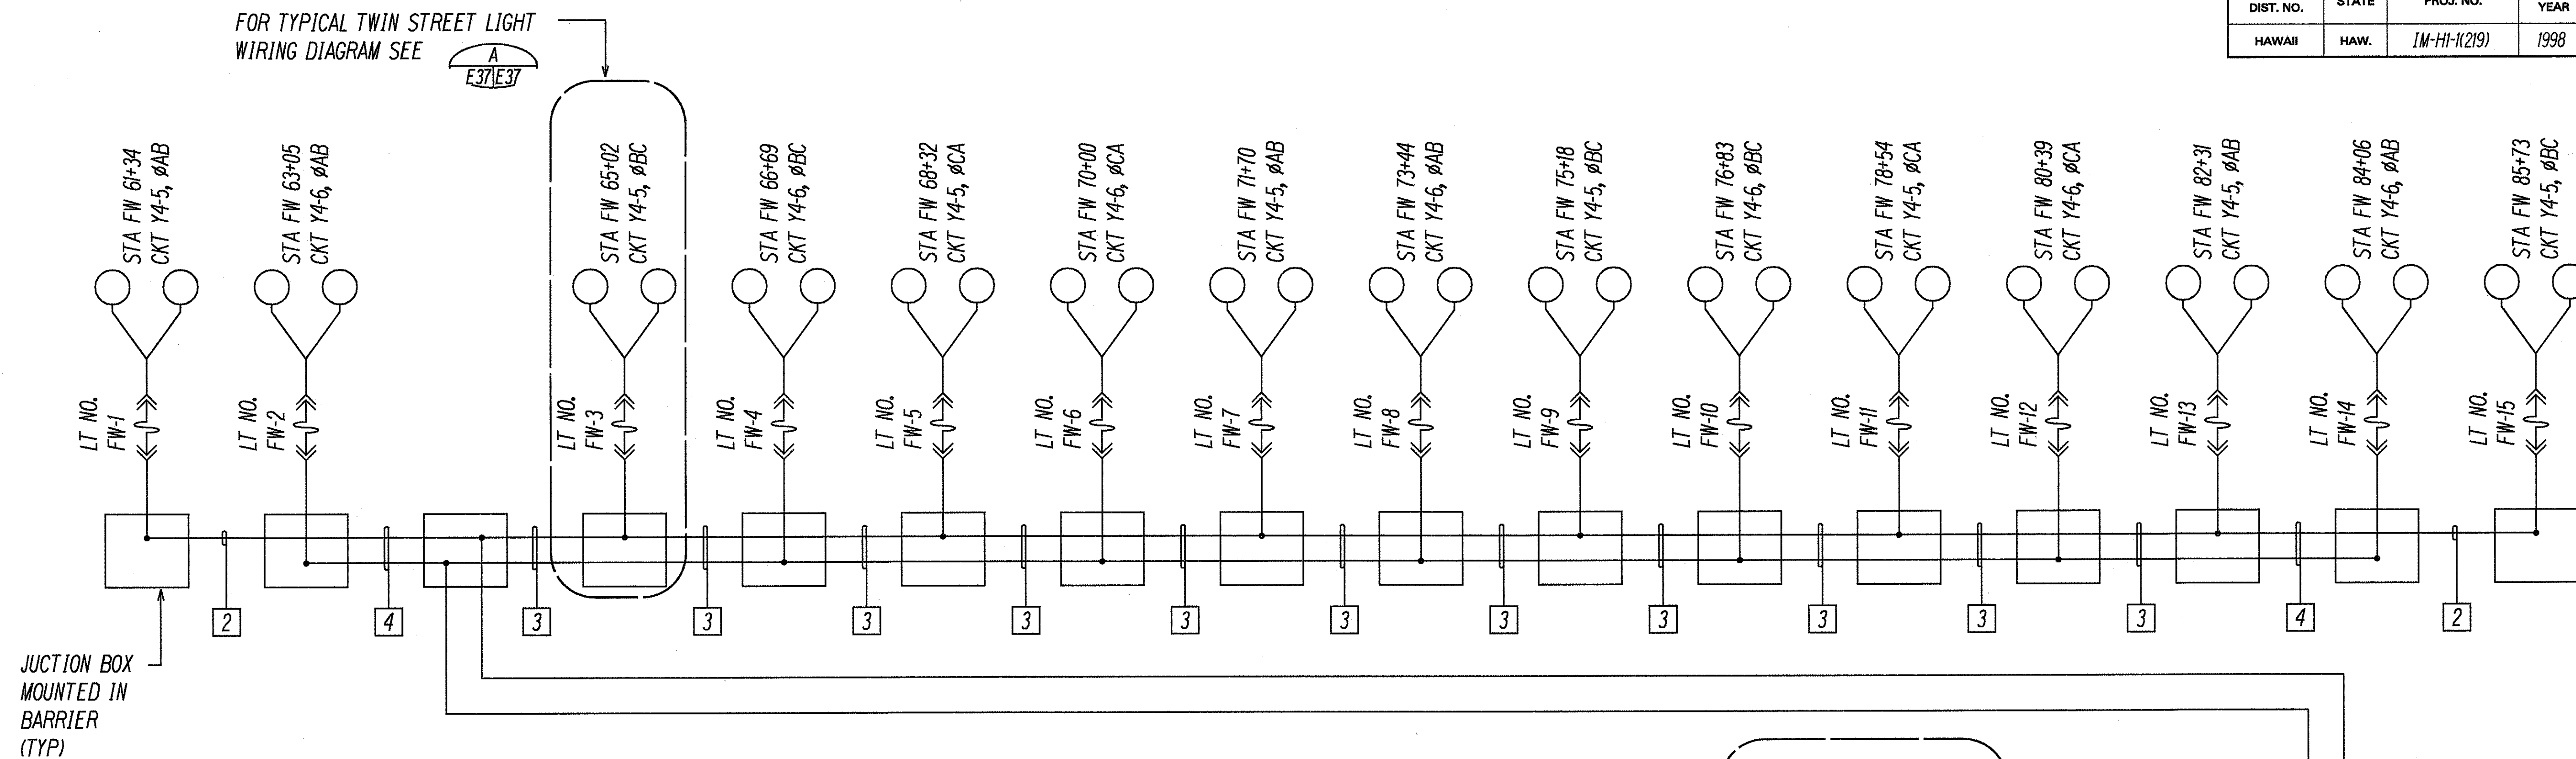


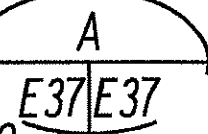 TYPICAL WIRING DIAGRAM OF TWIN STREET LIGHT STANDARD
E38, E39

NOTES:

- | | |
|--------------------------------|-------------------------------|
| 1 2" C, 3#1/0 RHW-USE, #6 GND. | 3 2" C, 6#4 RHW-USE, 2#6 GND. |
| 2 2" C, 2#4 RHW-USE, #6 GND. | 4 2" C, 4#4 RHW-USE, 2#6 GND. |

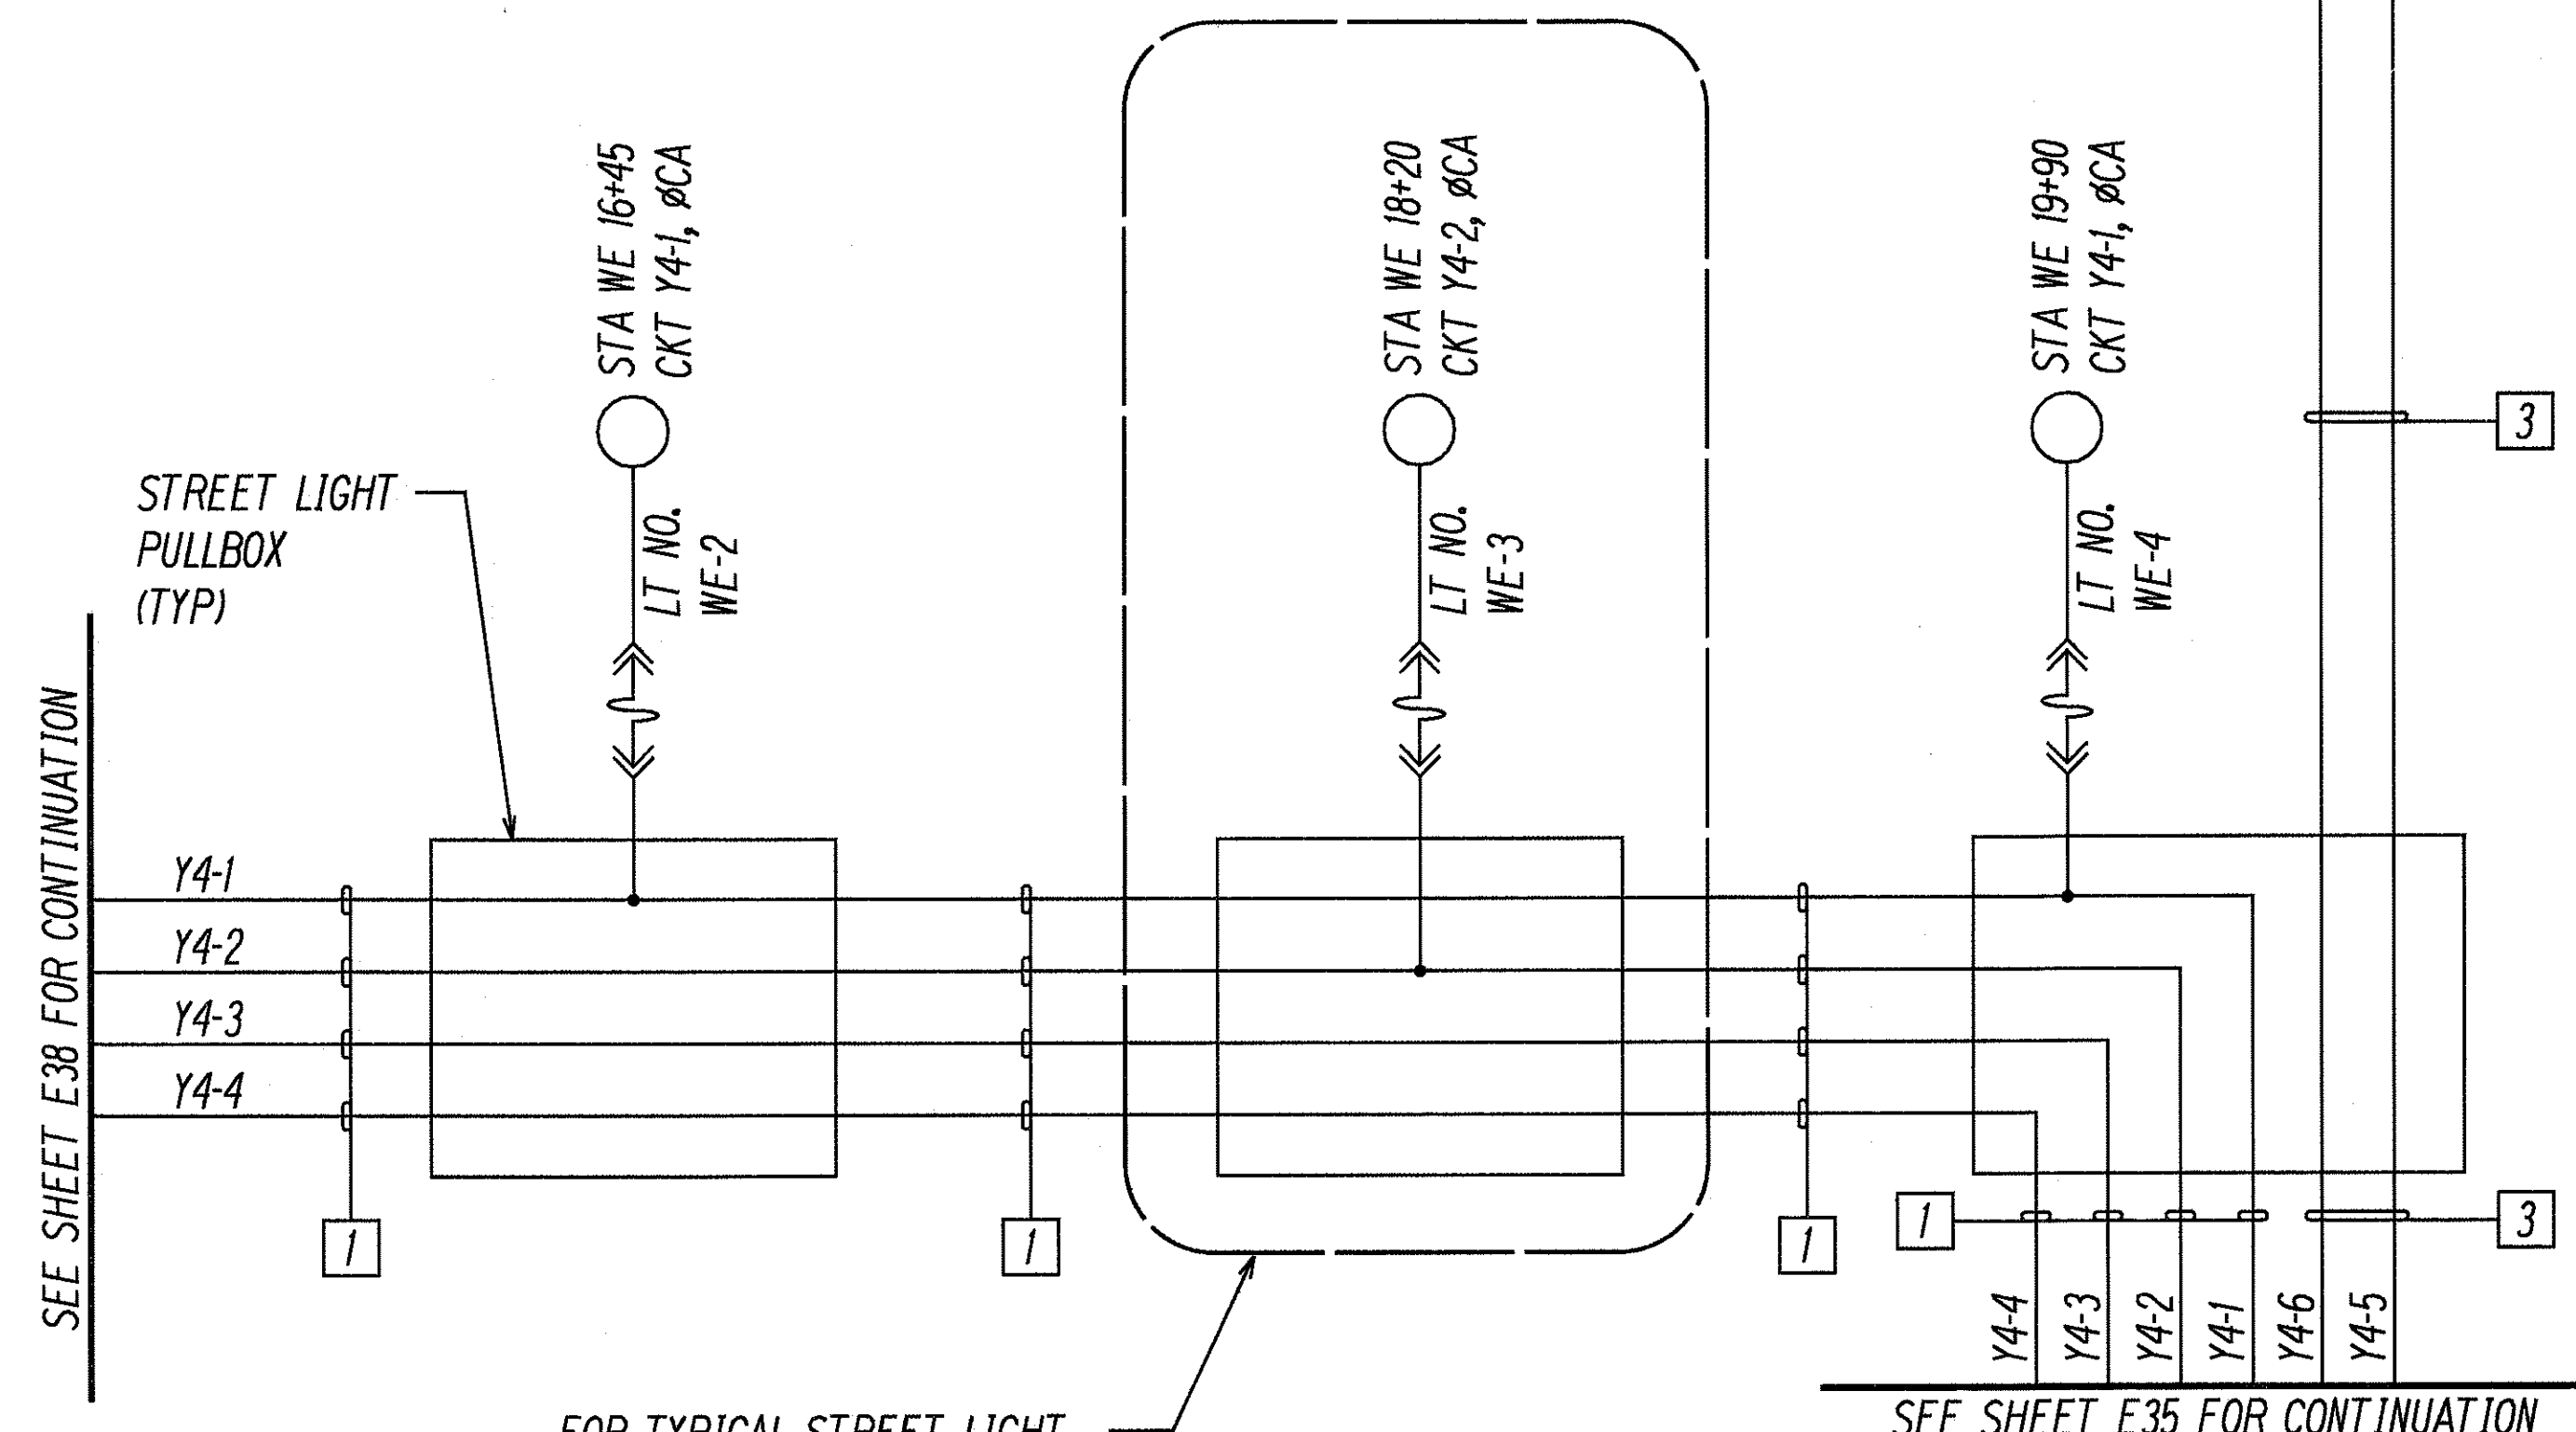

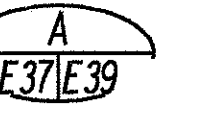FOR TYPICAL STREET LIGHT WIRING DIAGRAM SEE 

STREET LIGHT ONE-LINE DIAGRAM - I
NOT TO SCALE



THIS WORK WAS PREPARED BY ME OR UNDER MY SUPERVISION.
G. I. Funasaky
6 Nov 1999

STATE OF HAWAII
DEPARTMENT OF TRANSPORTATION
HIGHWAYS DIVISION


STREET LIGHT ONE-LINE DIAGRAM - I

INTERSTATE ROUTE H-1
Kunia Interchange Improvements
F.A.I. Project No 1M-HI-K219

SCALE: AS NOTED DATE: OCT. 1997

SHEET No. E37 OF 43 SHEETS

FED. ROAD DIST. NO.	STATE	FED. AID PROJ. NO.	FISCAL YEAR	SHEET NO.	TOTAL SHEETS
HAWAII	HAW.	1M-HI-K219	1998	259	378

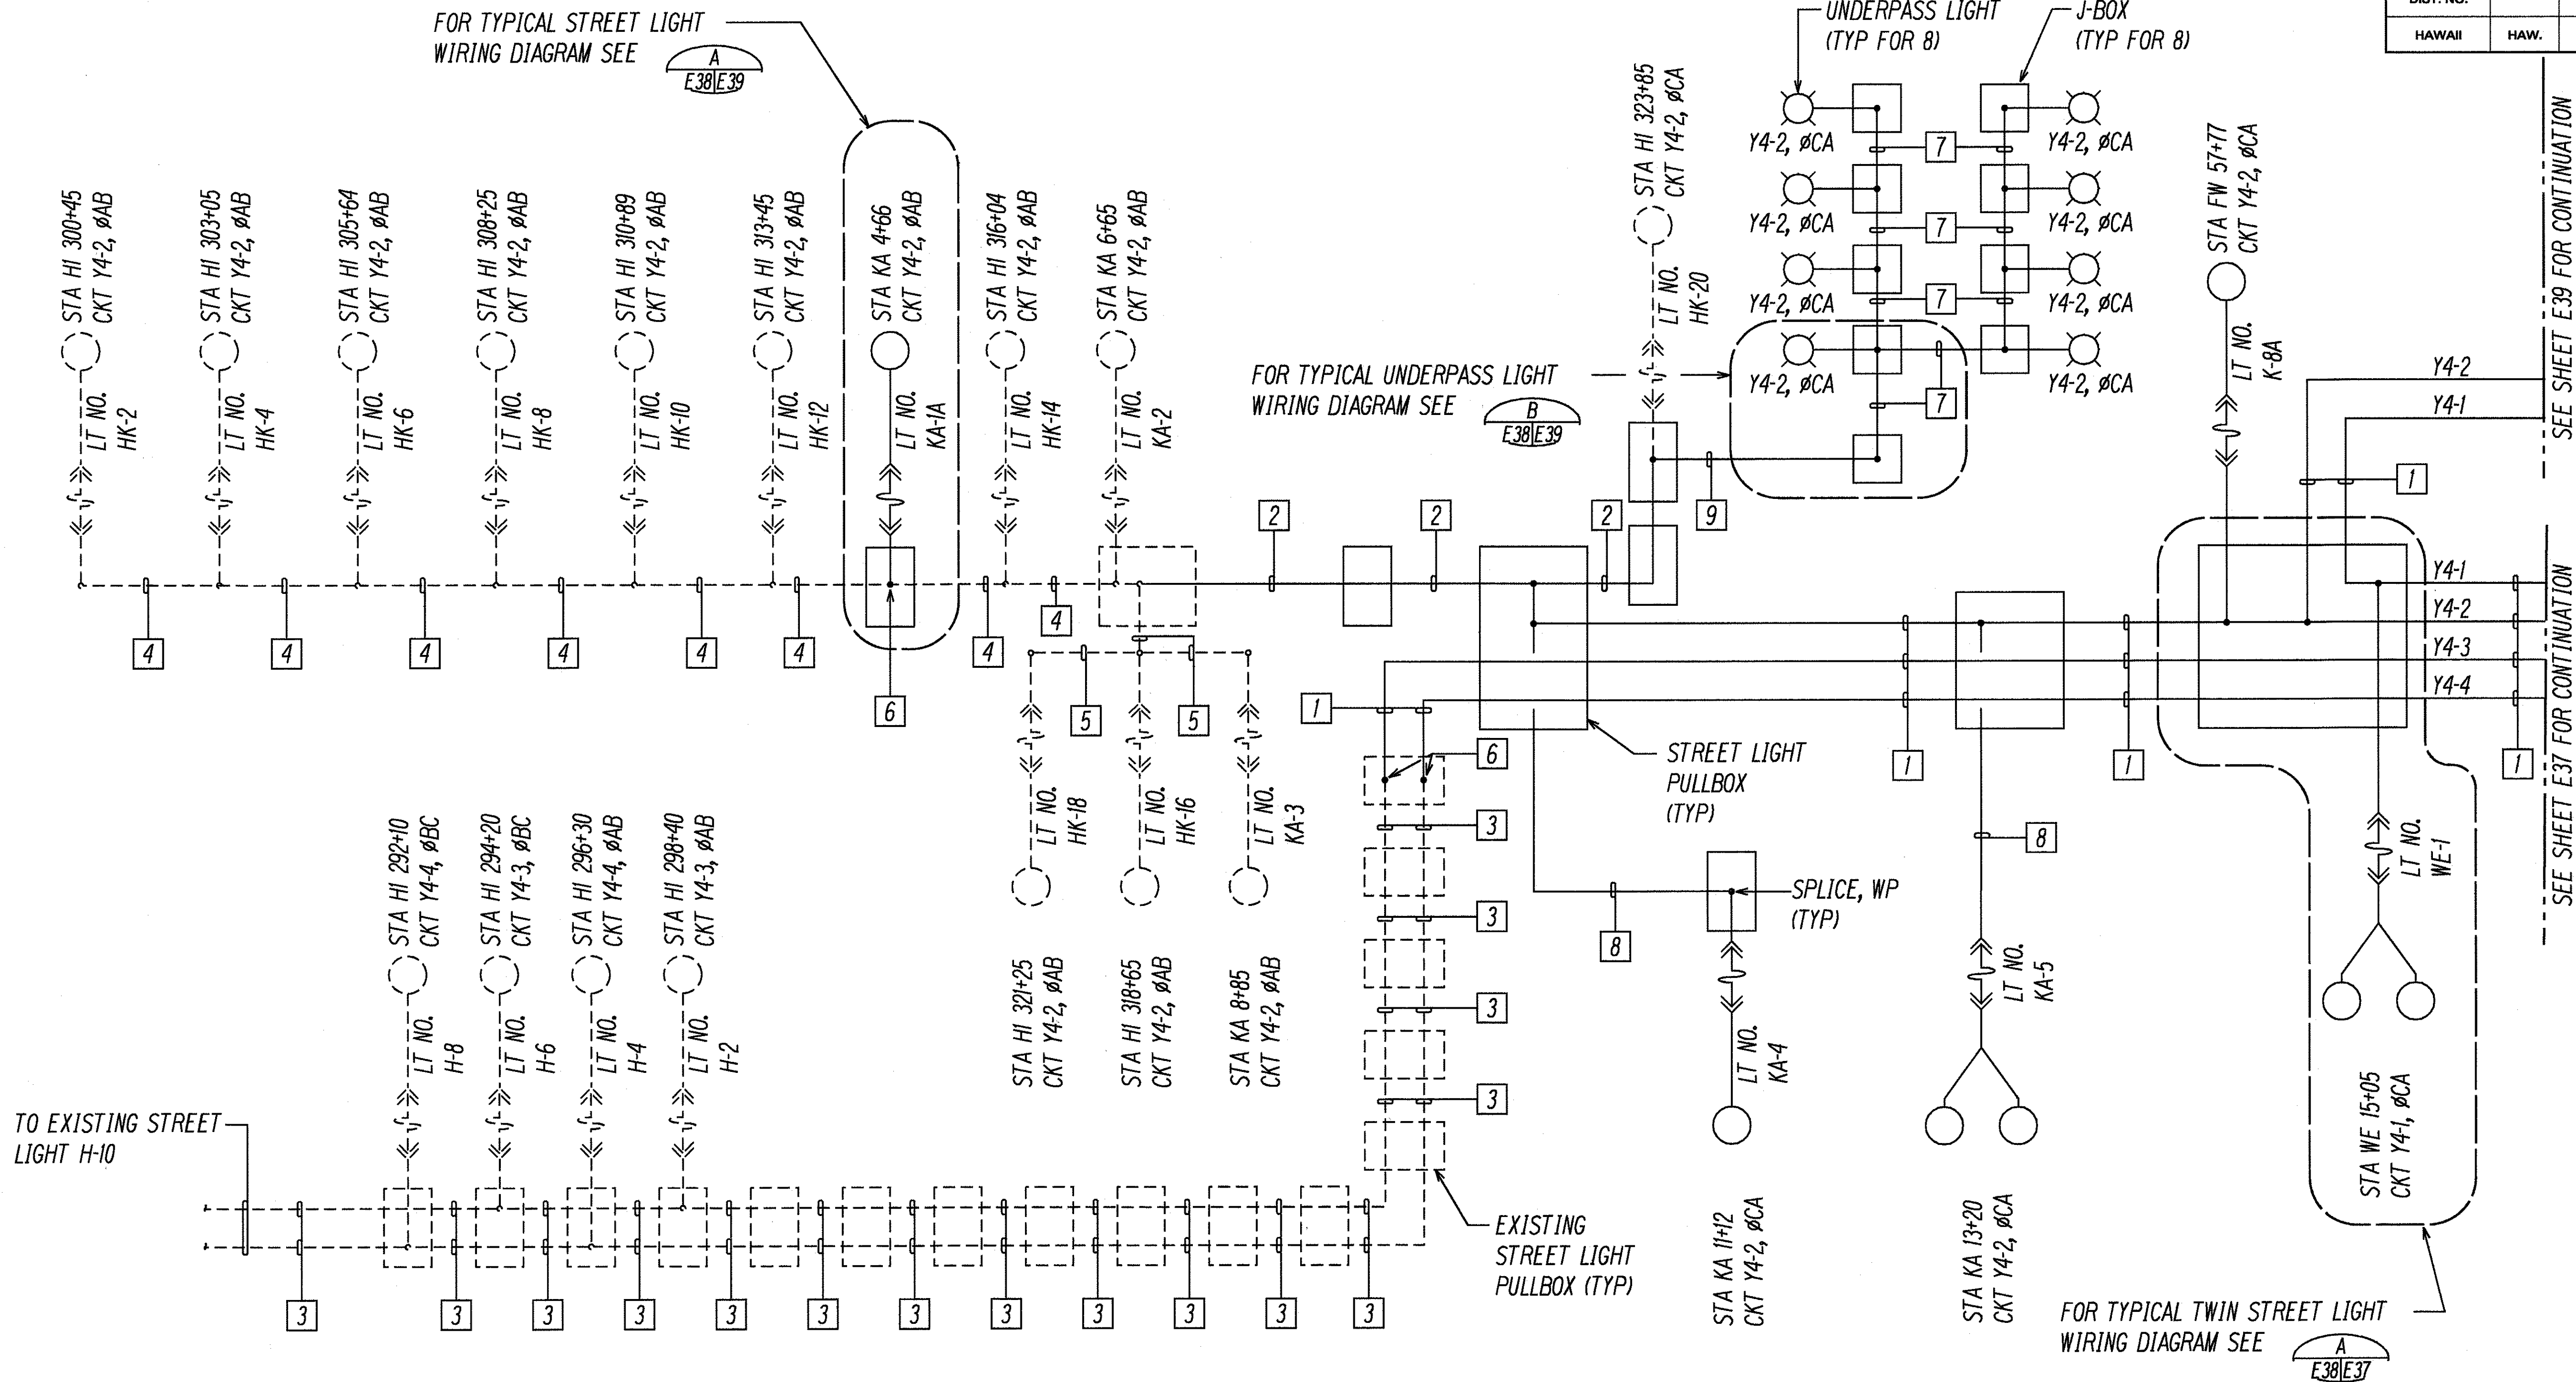

NOTES:

- 1 2" C, 3#1/0 RHW-USE, #6 GND.
- 2 2" C, 2#1/0 RHW-USE, #6 GND.
- 3 EXISTING 2" C, 3#2, #6 GND.
- 4 EXISTING 2#4 DIRECT BURIED CABLE.
- 5 EXISTING 2#8 DIRECT BURIED CABLE.
- 6 SPLICE TO EXISTING CABLE.
- 7 3/4" C PVC-COATED GRS, 2#10 RHW-USE, #10 GND.
- 8 2" C, 2#4 RHW-USE, #6 GND.
- 9 2" C, 2#6 RHW-USE, #8 GND.

STREET LIGHT ONE-LINE DIAGRAM - II
NOT TO SCALE



DATE	DESIGNED BY	CHECKED BY
10/30/98	DESIGNED BY	CHECKED BY
10/30/98	DESIGNED BY	CHECKED BY
THIS WORK WAS PREPARED BY ME OR UNDER MY SUPERVISION.

1/30/98	REVISED NOTE NO. 7 PER ADDENDUM NO. 2.
DATE	REVISION
STATE OF HAWAII DEPARTMENT OF TRANSPORTATION HIGHWAYS DIVISION	
STREET LIGHT ONE-LINE DIAGRAM - II	
INTERSTATE ROUTE H-1 Kunia Interchange Improvements F.A.I. Project No. 1M-HI-K219	
SCALE: AS NOTED	DATE: OCT. 1997
SHEET No. E38 OF 43 SHEETS	


FED. ROAD DIST. NO.	STATE	FED. AID PROJ. NO.	FISCAL YEAR	SHEET NO.	TOTAL SHEETS
HAWAII	HAW.	1M-HI-1(219)	1998	260	378

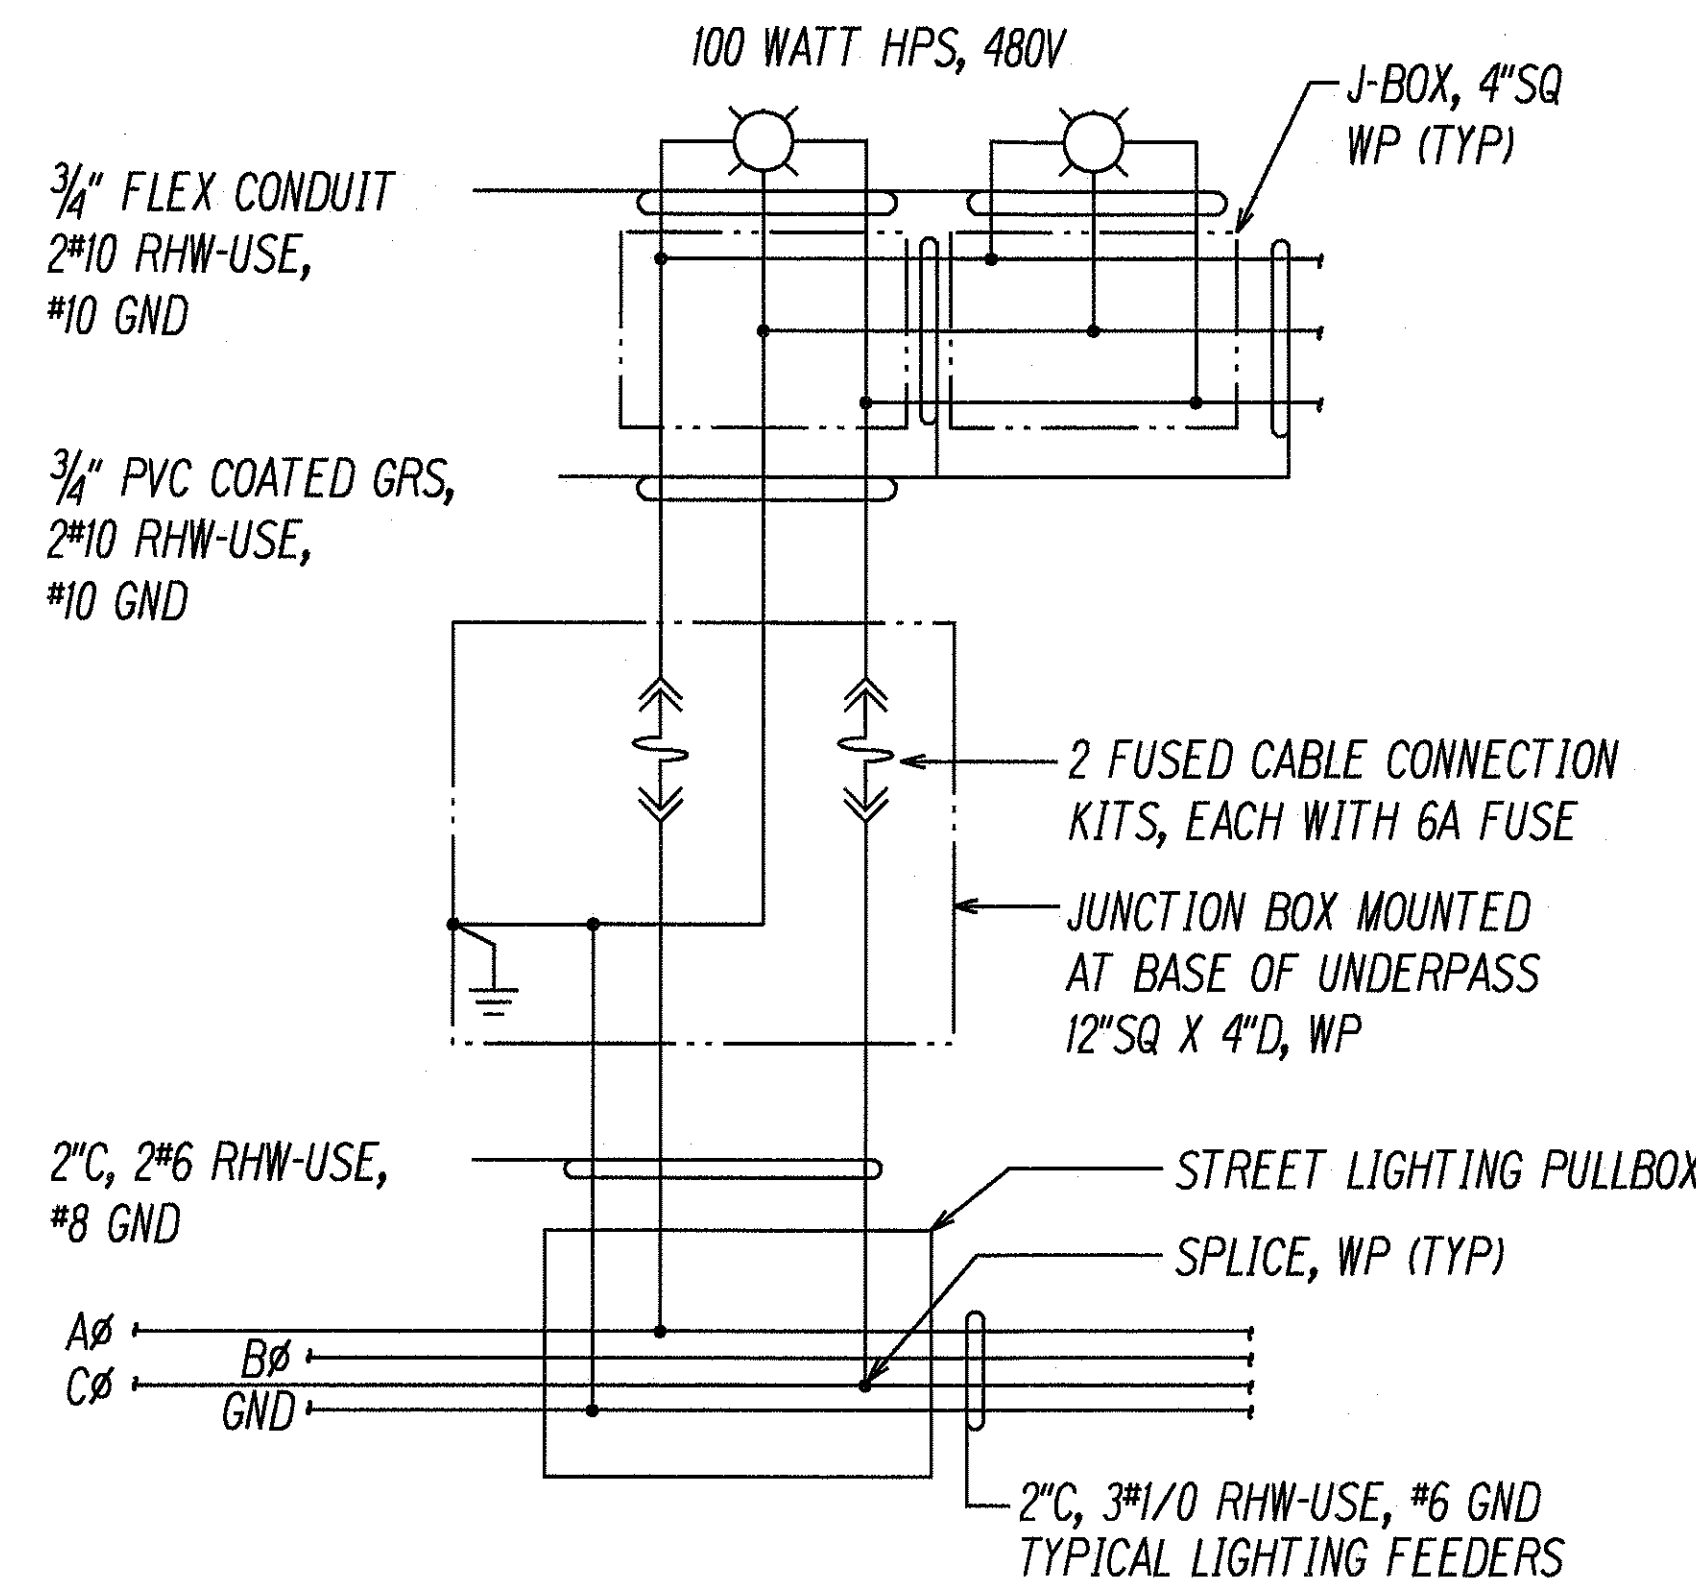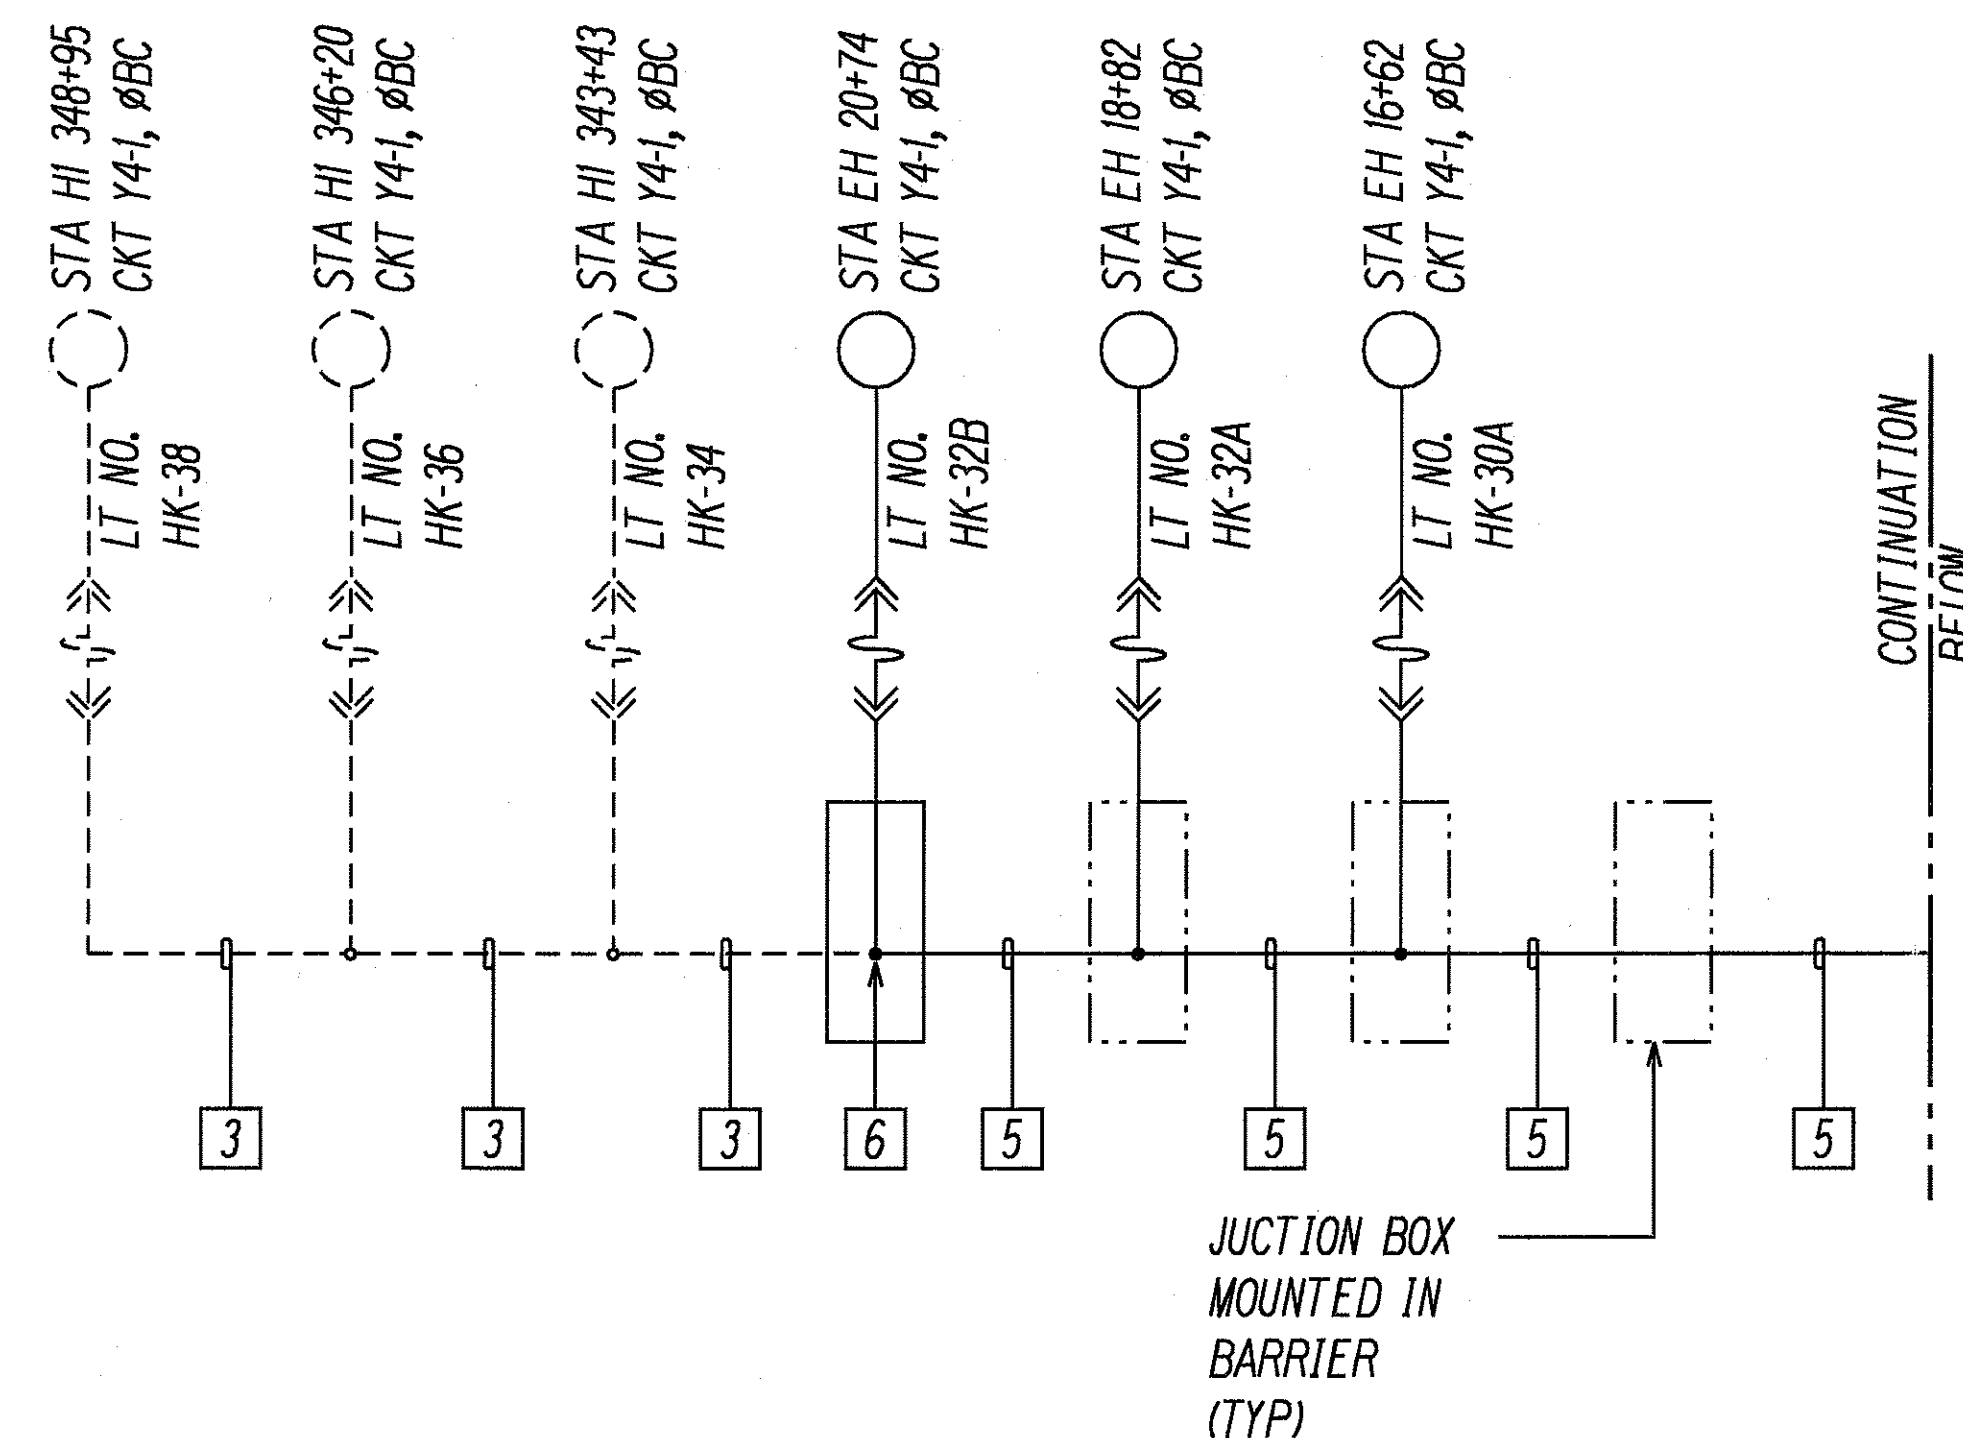

B
E38/E39
TYPICAL WIRING DIAGRAM OF UNDERPASS LIGHTING

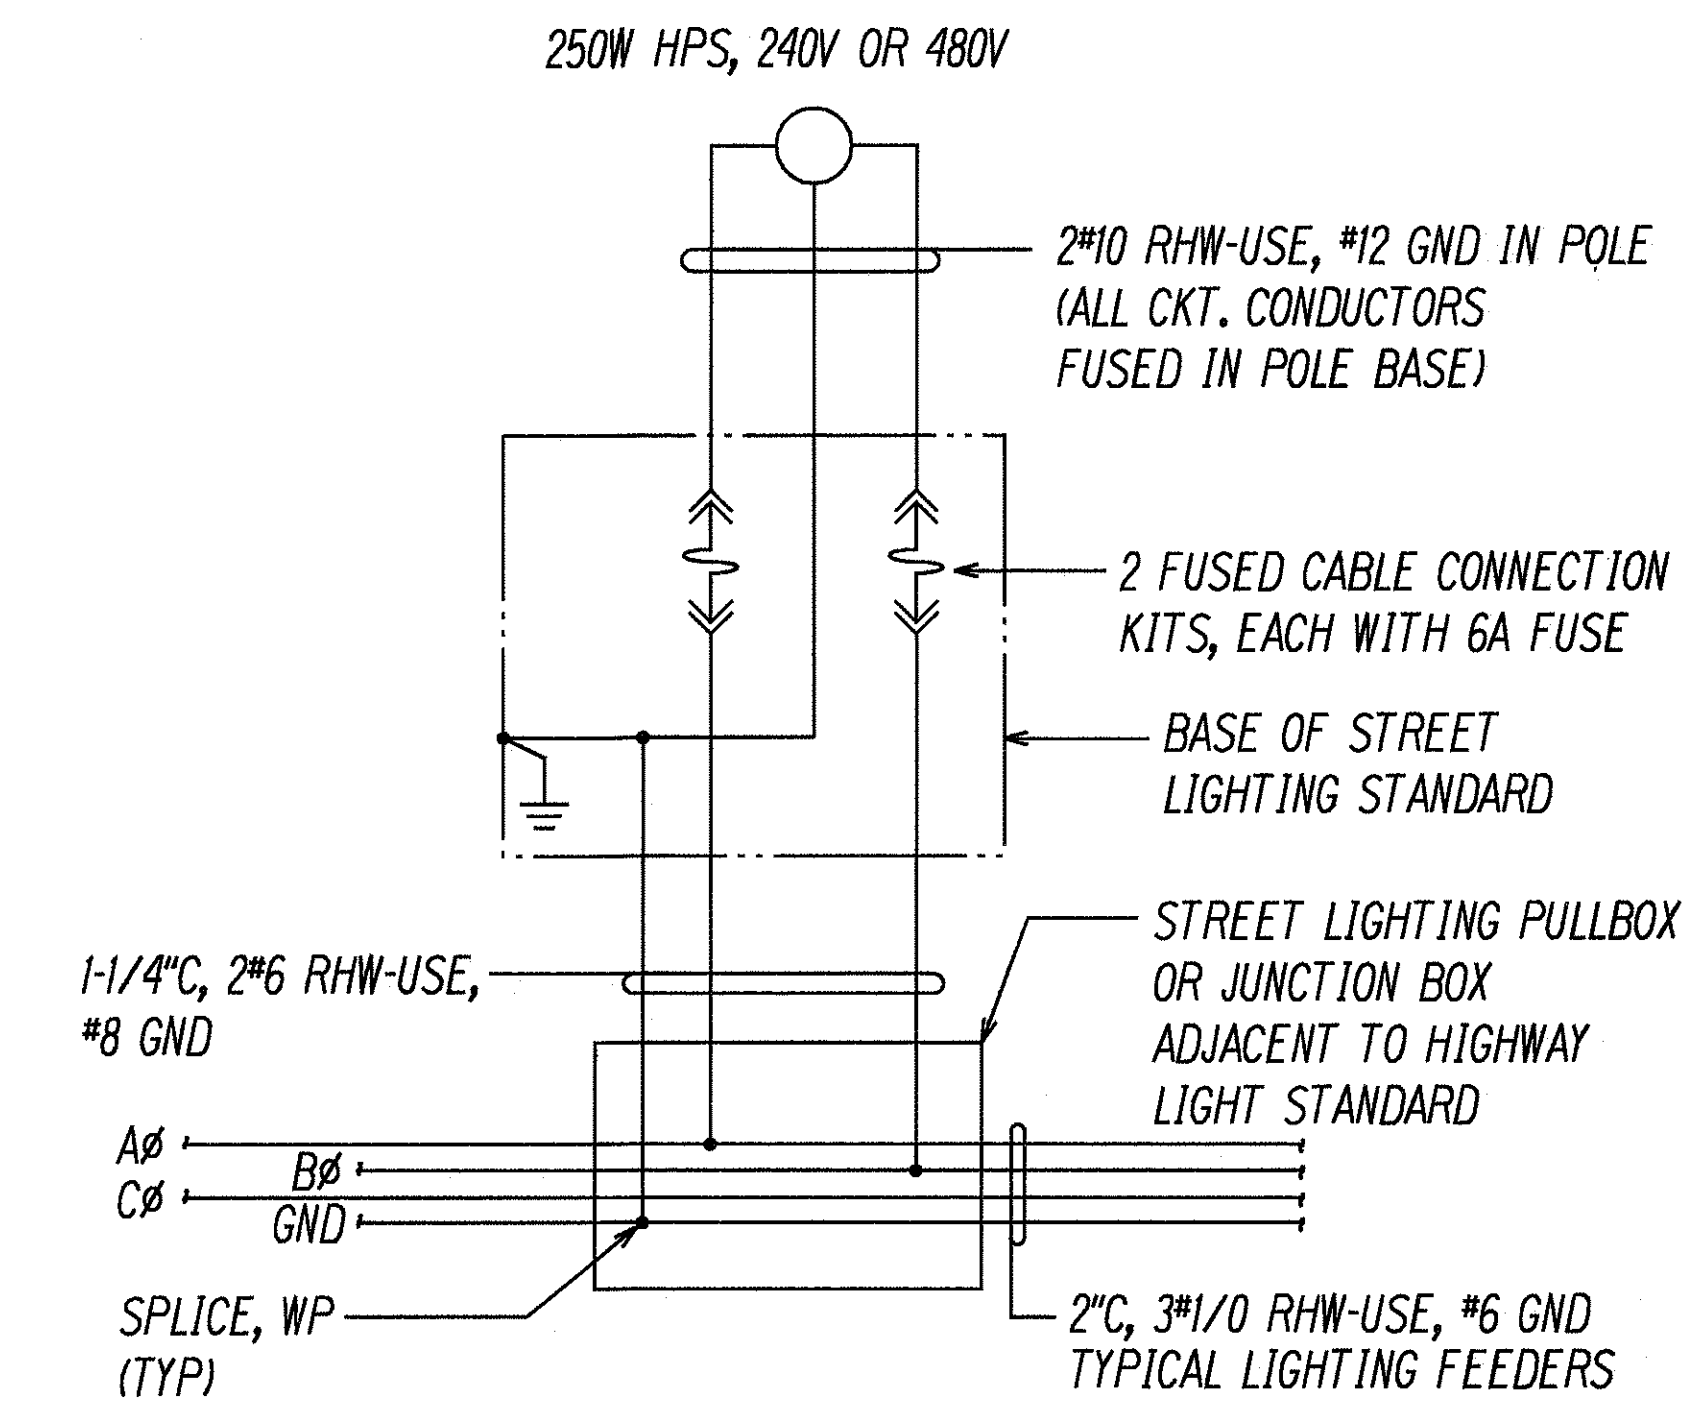

A
E37/E39
TYPICAL WIRING DIAGRAM OF STREET LIGHT STANDARD

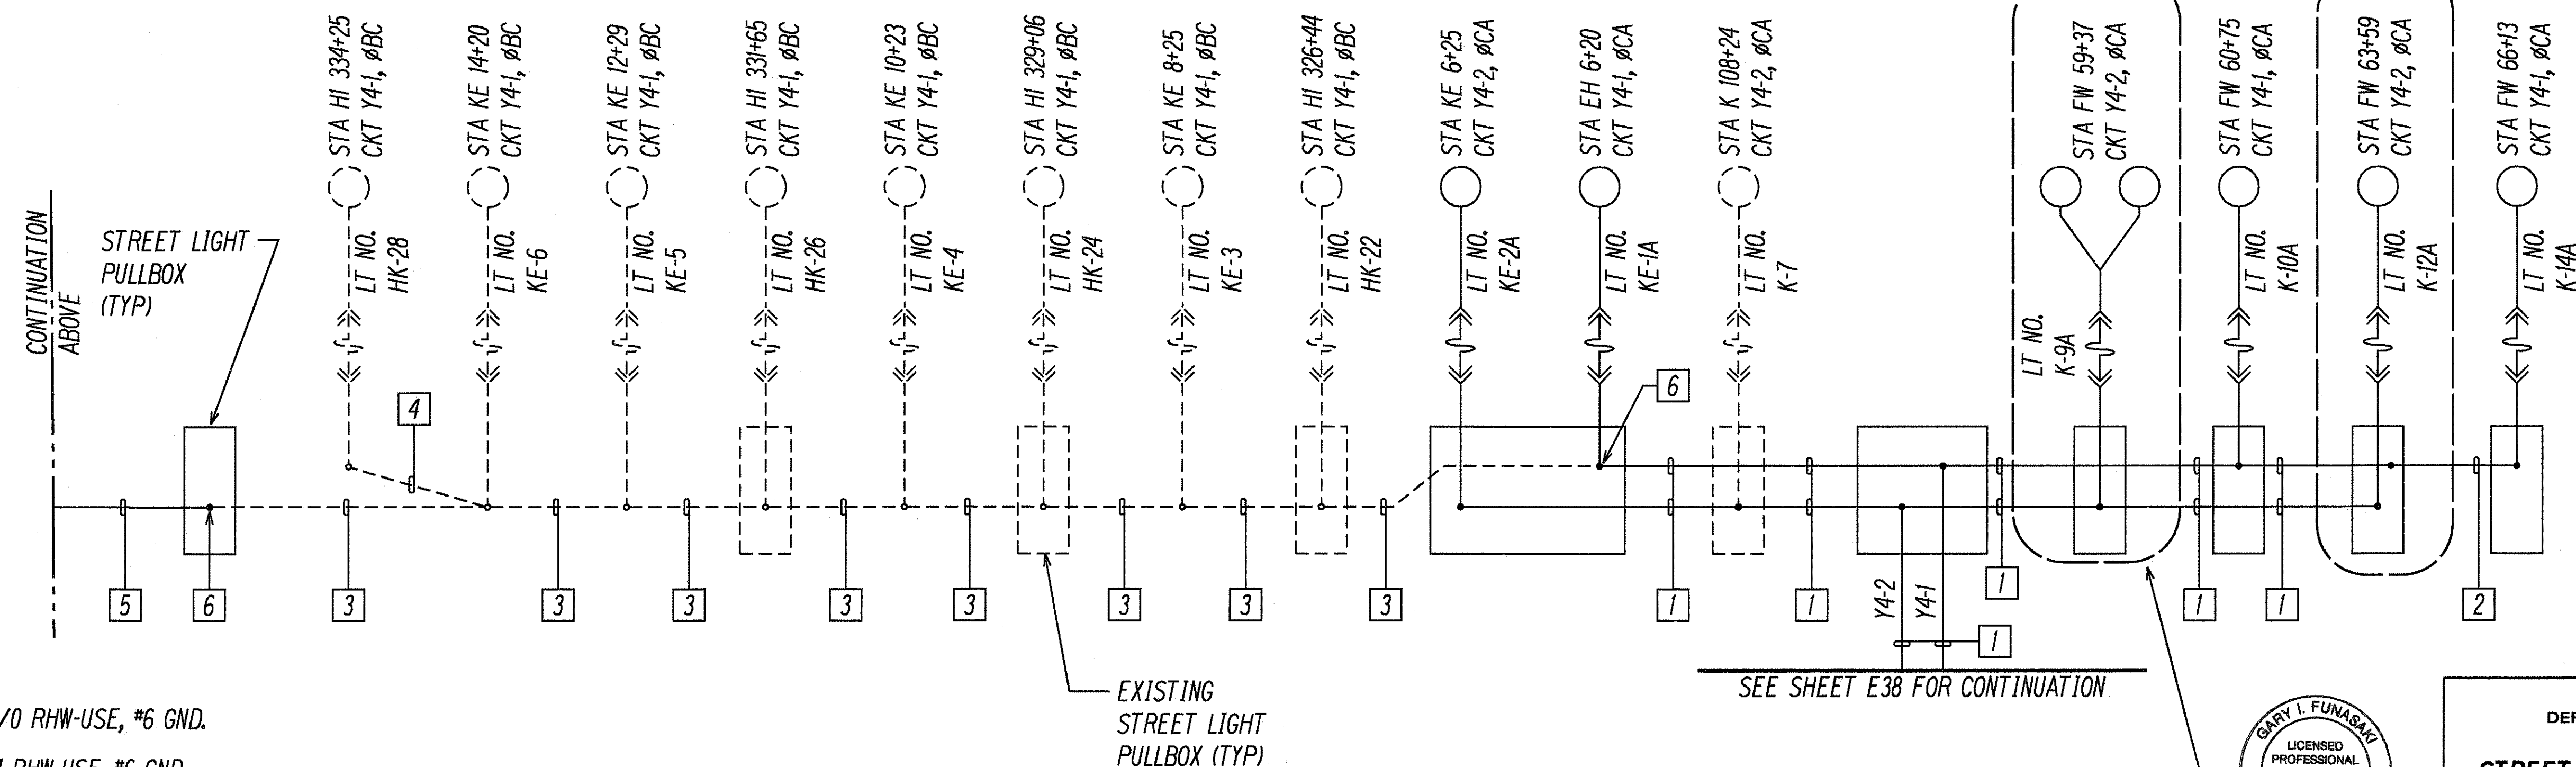

- NOTES:**
- 2"C, 3#1/0 RHW-USE, #6 GND.
 - 2"C, 2#4 RHW-USE, #6 GND.
 - EXISTING 2#2 DIRECT BURIED CABLE.
 - EXISTING 2#8 DIRECT BURIED CABLE.
 - 2"C, 2#1/0 RHW-USE, #6 GND.
 - SPLICE TO EXISTING CABLE.

STREET LIGHT ONE-LINE DIAGRAM - III
NOT TO SCALE

SEE SHEET E38 FOR CONTINUATION

FOR TYPICAL TWIN STREET LIGHT WIRING DIAGRAM SEE **A** E39/E37



STATE OF HAWAII
DEPARTMENT OF TRANSPORTATION
HIGHWAYS DIVISION

STREET LIGHT ONE-LINE DIAGRAM - III

**INTERSTATE ROUTE H-1
Kunia Interchange Improvements
F.A.I. Project No 1M-HI-1(219)**

SCALE: AS NOTED DATE: OCT. 1997

SHEET No. E39 OF 43 SHEETS

FED. ROAD DIST. NO.	STATE	FED. AID PROJ. NO.	FISCAL YEAR	SHEET NO.	TOTAL SHEETS
HAWAII	HAW.	1M-HI-K(219)	1998	261	378

TO EXISTING STREET LIGHT H-9

EXISTING STREET LIGHT PULLBOX (TYP)

STA HI 293+10
CKT Z4-4, ØBC

STA HI 291+00
CKT Z4-3, ØBC

STA EW 1+13
CKT Z4-2, ØBC

STA EW 3+26
CKT Z4-1, ØBC

STA EW 5+28
CKT Z4-2, ØAB

STA EW 7+25
CKT Z4-1, ØAB

STA EW 9+25
CKT Z4-2, ØCA

STA EW 11+25
CKT Z4-1, ØCA

STA EW 14+00
CKT Z4-2, ØBC

STA EW 16+00
CKT Z4-1, ØBC

STA EW 18+10
CKT Z4-2, ØAB

STA EW 20+10
CKT Z4-1, ØAB

STA EW 22+10
CKT Z4-2, ØCA

STA EW 24+08
CKT Z4-1, ØCA

STA EW 26+05
CKT Z4-2, ØBC

STA EW 28+02
CKT Z4-1, ØBC

STA EW 30+02
CKT Z4-2, ØAB

STA EW 32+00
CKT Z4-1, ØAB

Z4-3
Z4-4
Z4-1
Z4-2
Z4-5
Z4-6

SEE SHEET E36 FOR CONTINUATION

FOR TYPICAL STREET LIGHT WIRING DIAGRAM SEE



STA HE 33+19
CKT ZA-5, ØBC

STA HE 31+06
CKT Z4-6, ØBC

STA HE 29+46
CKT Z4-5, ØAB

STA HE 27+74
CKT Z4-6, ØAB

STA HE 25+66
CKT Z4-5, ØCA

STA HE 23+17
CKT Z4-6, ØCA

STA HE 21+79
CKT Z4-5, ØBC

STA HE 20+15
CKT Z4-6, ØBC

STA HE 18+18
CKT Z4-5, ØAB

STA HE 16+20
CKT Z4-6, ØAB

STA HE 14+26
CKT Z4-5, ØCA

STA HE 12+26
CKT Z4-6, ØCA

STA HE 10+23
CKT Z4-5, ØBC

STA HE 8+23
CKT Z4-6, ØBC

STA HE 6+29
CKT Z4-5, ØAB

STA HE 0+65
CKT Z4-6, ØAB

NOTES:

- 1 2"C, 3#1/0 RHW-USE, #6 GND.
- 2 2"C, 2#4 RHW-USE, #6 GND.
- 3 SPLICE TO EXISTING STREET LIGHT CIRCUIT.
- 4 EXISTING 2"C, 3#2, #6 GND.

SEE ABOVE

STA HI 307+49
CKT Z4-1, ØAB

STA HI 309+70
CKT Z4-2, ØAB

STA HI 317+44
CKT Z4-5, ØCA


STA HI 314+71
CKT Z4-6, ØBC

STA HI 312+20
CKT Z4-5, ØBC

STREET LIGHT PULLBOX (TYP)

SPLICE, WP (TYP)

STREET LIGHT ONE-LINE DIAGRAM - IV
NOT TO SCALE

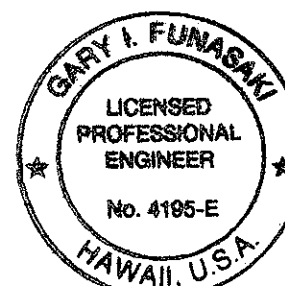


THIS WORK WAS PREPARED BY ME OR UNDER MY SUPERVISION
6 NOV 1997

STATE OF HAWAII
DEPARTMENT OF TRANSPORTATION
HIGHWAYS DIVISION
STREET LIGHT ONE-LINE DIAGRAM - IV

INTERSTATE ROUTE H-1
Kunia Interchange Improvements
F.A.I. Project No. 1M-HI-K(219)

SCALE: AS NOTED DATE: OCT. 1997
SHEET No. E40 OF 43 SHEETS


FED. ROAD DIST. NO.	STATE	FED. AID PROJ. NO.	FISCAL YEAR	SHEET NO.	TOTAL SHEETS
HAWAII	HAW.	1M-HI-1(219)	1998	262	378

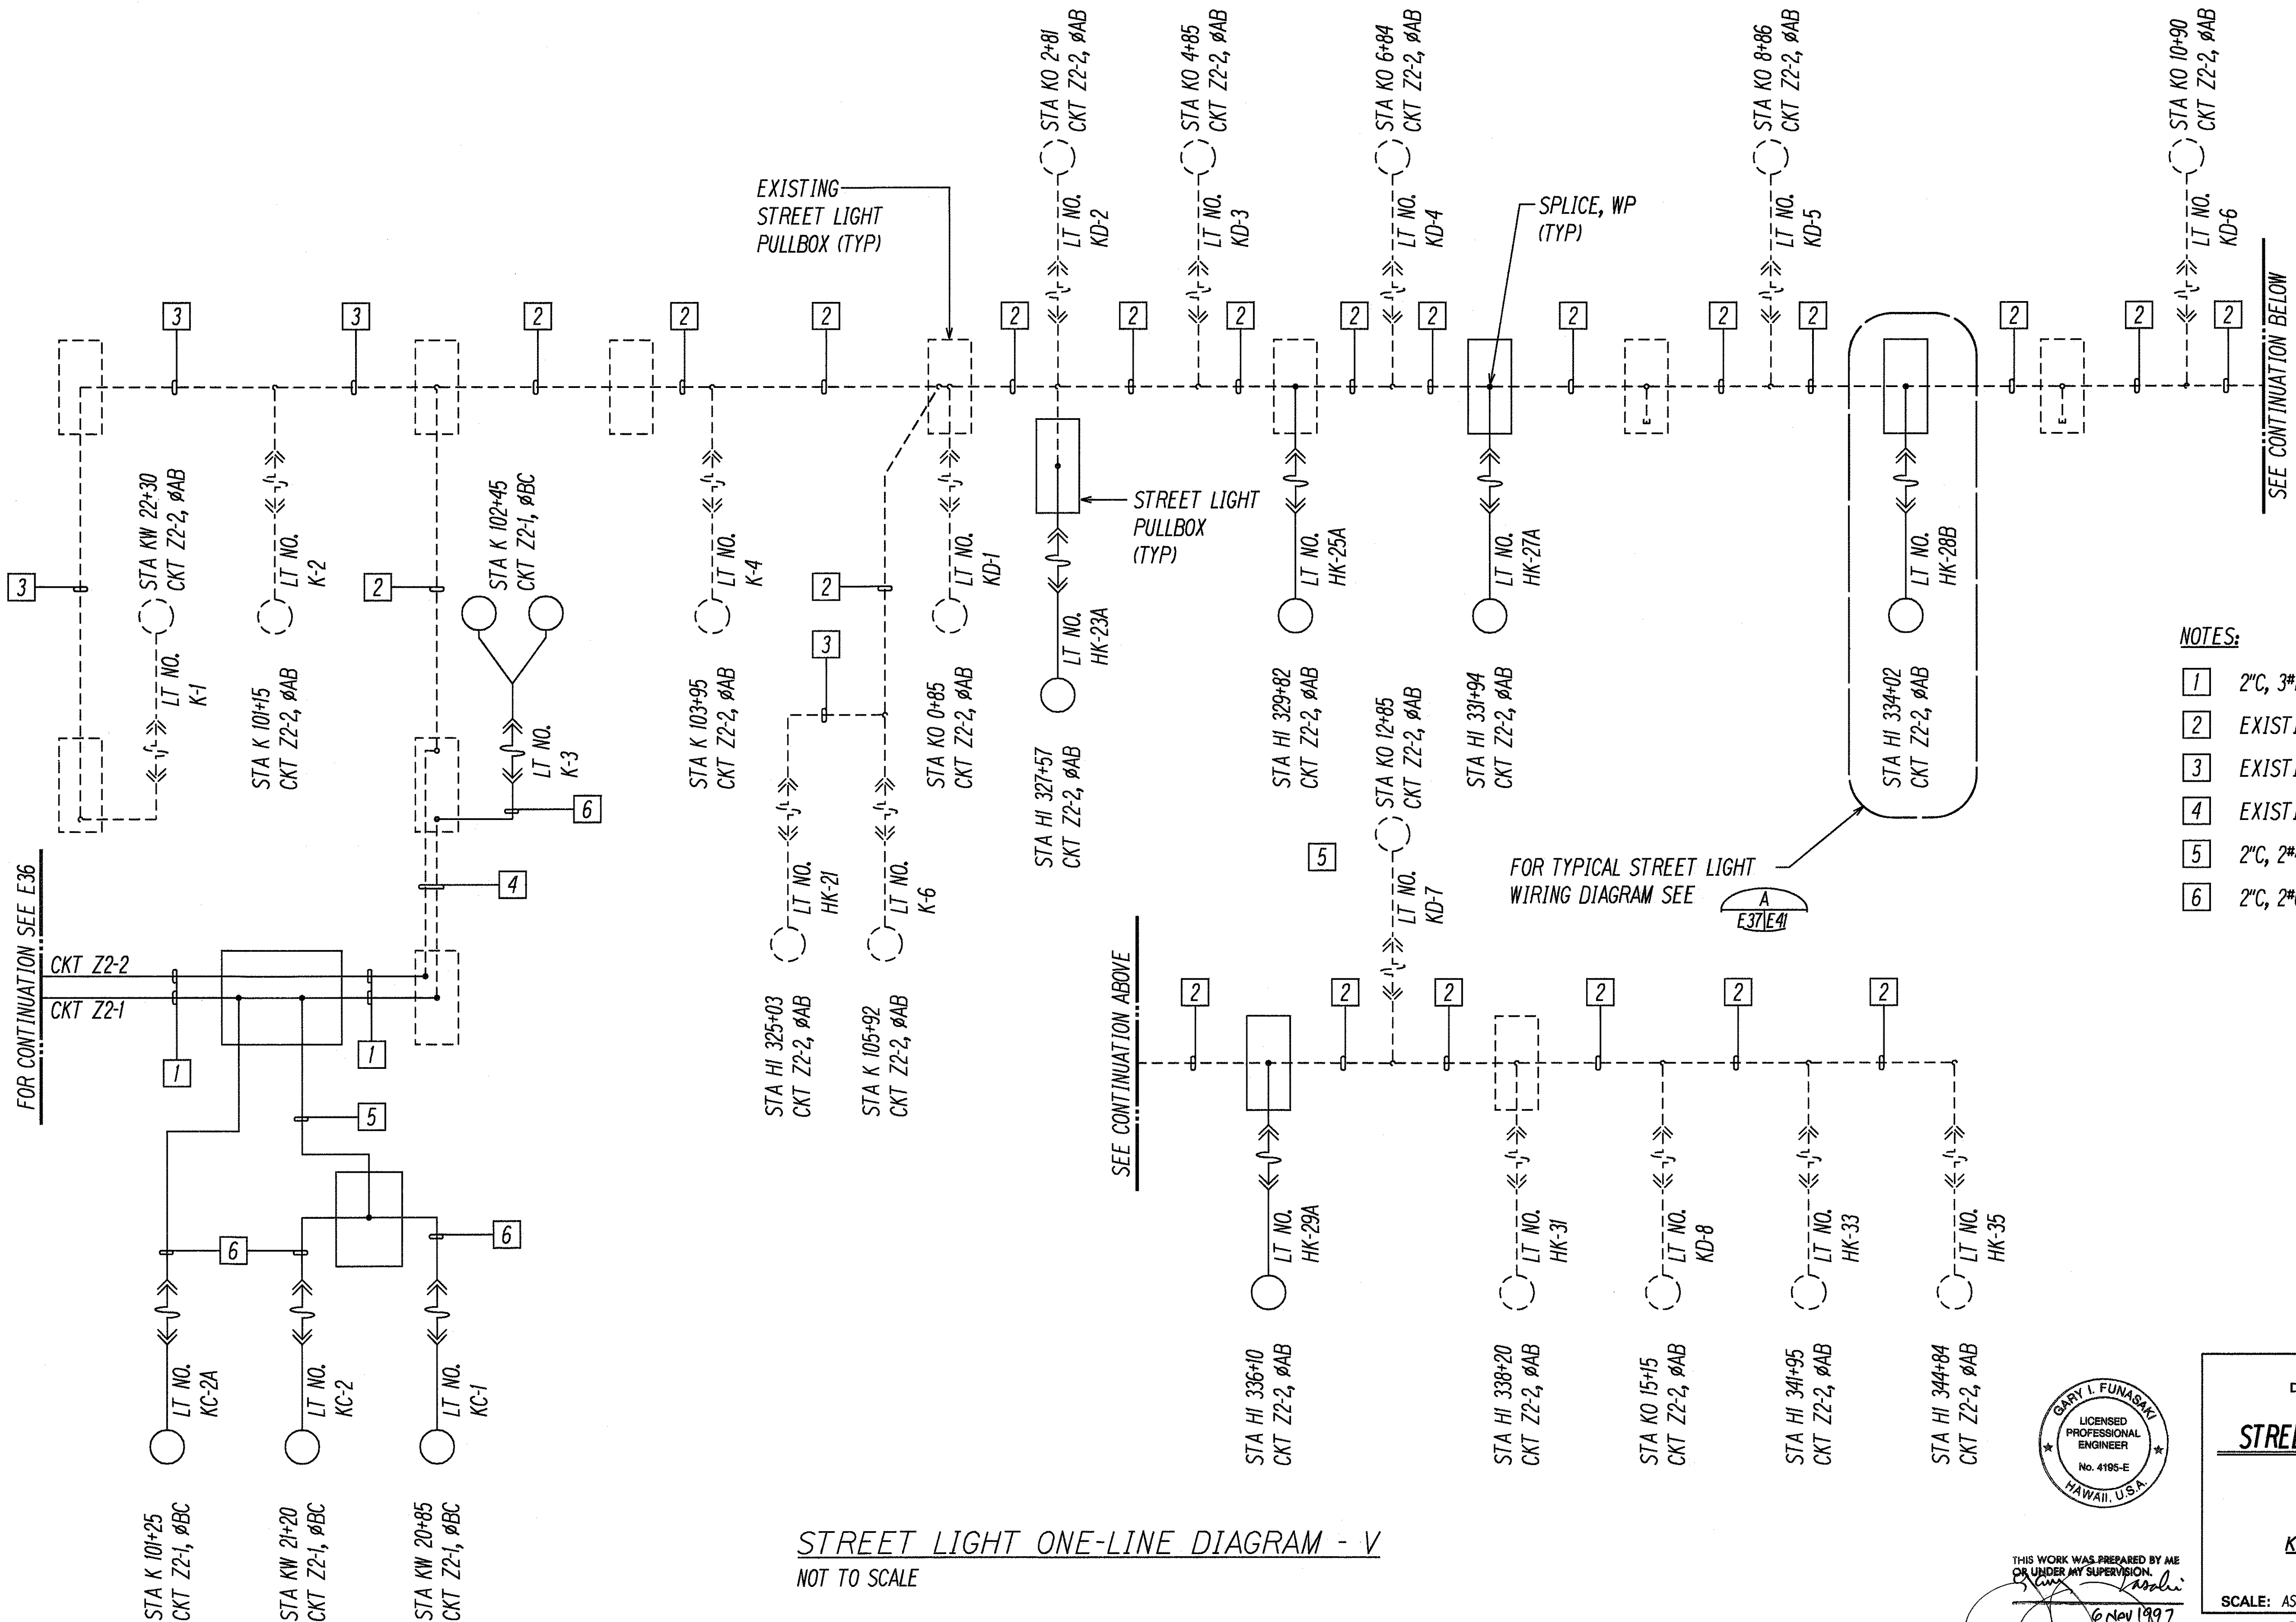

- NOTES:
- 1 2"C, 3#1/0 RHW-USE, #6 GND.
 - 2 EXISTING 2#2 DIRECT BURIED CABLE.
 - 3 EXISTING 2#8 DIRECT BURIED CABLE.
 - 4 EXISTING 2"C, 2#2, 2#8.
 - 5 2"C, 2#4 RHW-USE, #6 GND.
 - 6 2"C, 2#6 RHW-USE, #6 GND.

ORIGINAL PLAN	DATE
DESIGNED BY	
NOTED BY	
CHECKED BY	
IN CHARGE	

LAST SAVE: 10/10/97 @ 10:40 AM BY: GARY I. FUNASAKI
 6 NOV 1997

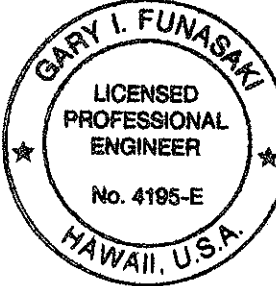


STATE OF HAWAII
 DEPARTMENT OF TRANSPORTATION
 HIGHWAYS DIVISION

STREET LIGHT ONE-LINE DIAGRAM - V

INTERSTATE ROUTE H-1
 Kunia Interchange Improvements
 F.A.I. Project No. 1M-HI-1(219)

SCALE: AS NOTED DATE: OCT. 1997
 SHEET No. E41 OF 43 SHEETS

HIGHWAY LIGHT STA. NUMBER	ID TAG ITEMS						HIGHWAY LIGHT STA. NUMBER	ID TAG ITEMS					
	LIGHT POLE NO.	METER NO.	CIRCUIT NO.	LINE VOLTAGE	LAMP DATA	REFRACTOR DATA		LIGHT POLE NO.	METER NO.	CIRCUIT NO.	LINE VOLTAGE	LAMP DATA	REFRACTOR DATA
H-1 300+45	HK-2	Y	Y4-2ØAB	480V	N250	MSIII	FW 66+13	K-14A	Y	Y4-1ØCA	480V	N250	MSIII
H-1 303+05	HK-4	Y	Y4-2ØAB	480V	N250	MSIII	WE 15+05	WE-1	Y	Y4-1ØCA	480V	N250	MSIII
H-1 305+64	HK-6	Y	Y4-2ØAB	480V	N250	MSIII	WE 16+45	WE-2	Y	Y4-1ØCA	480V	N250	MSIII
H-1 308+25	HK-8	Y	Y4-2ØAB	480V	N250	MSIII	WE 18+20	WE-3	Y	Y4-2ØCA	480V	N250	MSIII
H-1 310+89	HK-10	Y	Y4-2ØAB	480V	N250	MSIII	WE 19+90	WE-4	Y	Y4-1ØCA	480V	N250	MSIII
H-1 313+45	HK-12	Y	Y4-2ØAB	480V	N250	MSIII	FW 61+34	FW-1	Y	Y4-5ØAB	480V	N250	MSIII
H-1 316+04	HK-14	Y	Y4-2ØAB	480V	N250	MSIII	FW 63+05	FW-2	Y	Y4-6ØAB	480V	N250	MSIII
H-1 318+65	HK-16	Y	Y4-2ØAB	480V	N250	MSIII	FW 65+02	FW-3	Y	Y4-5ØBC	480V	N250	MSIII
H-1 321+25	HK-18	Y	Y4-2ØAB	480V	N250	MSIII	FW 66+69	FW-4	Y	Y4-6ØBC	480V	N250	MSIII
H-1 323+85	HK-20	Y	Y4-2ØCA	480V	N250	MSIII	FW 68+32	FW-5	Y	Y4-5ØCA	480V	N250	MSIII
H-1 326+44	HK-22	Y	Y4-1ØBC	480V	N250	MSIII	FW 70+00	FW-6	Y	Y4-6ØCA	480V	N250	MSIII
H-1 329+06	HK-24	Y	Y4-1ØBC	480V	N250	MSIII	FW 71+70	FW-7	Y	Y4-5ØAB	480V	N250	MSIII
H-1 331+65	HK-26	Y	Y4-1ØBC	480V	N250	MSIII	FW 73+44	FW-8	Y	Y4-6ØAB	480V	N250	MSIII
H-1 334+25	HK-28	Y	Y4-1ØBC	480V	N250	MSIII	FW 75+18	FW-9	Y	Y4-5ØBC	480V	N250	MSIII
EH 16+62	HK-30A	Y	Y4-1ØBC	480V	N250	MSIII	FW 76+83	FW-10	Y	Y4-6ØBC	480V	N250	MSIII
EH 18+82	HK-32A	Y	Y4-1ØBC	480V	N250	MSIII	FW 78+54	FW-11	Y	Y4-5ØCA	480V	N250	MSIII
EH 20+74	HK-34A	Y	Y4-1ØBC	480V	N250	MSIII	FW 80+39	FW-12	Y	Y4-6ØCA	480V	N250	MSIII
HI 343+43	HK-34	Y	Y4-1ØBC	480V	N250	MSIII	FW 82+31	FW-13	Y	Y4-5ØAB	480V	N250	MSIII
HI 346+20	HK-36	Y	Y4-1ØBC	480V	N250	MSIII	FW 84+06	FW-14	Y	Y4-6ØAB	480V	N250	MSIII
HI 348+95	HK-38	Y	Y4-1ØBC	480V	N250	MSIII	FW 85+73	FW-15	Y	Y4-5ØBC	480V	N250	MSIII
WE 4+66	KA-1A	Y	Y4-2ØAB	480V	N250	MSIII	HI 298+40	H-2	Y	Y4-3ØAB	480V	N250	MSIII
WE 6+65	KA-2	Y	Y4-2ØAB	480V	N250	MSIII	HI 296+30	H-4	Y	Y4-4ØAB	480V	N250	MSIII
WE 8+85	KA-3	Y	Y4-2ØAB	480V	N250	MSIII	HI 294+20	H-6	Y	Y4-3ØBC	480V	N250	MSIII
WE 11+05	KA-4	Y	Y4-2ØCA	480V	N250	MSIII	HI 292+10	H-8	Y	Y4-4ØBC	480V	N250	MSIII
WE 13+15	KA-5	Y	Y4-2ØCA	480V	N250	MSIII	KA 11+12	KA-4	Y	Y4-2ØCA	480V	N250	MSIII
EH 6+20	KE-1A	Y	Y4-1ØCA	480V	N250	MSIII	KA 13+20	KA-5	Y	Y4-2ØCA	480V	N250	MSIII
KE 6+25	KE-2A	Y	Y4-2ØCA	480V	N250	MSIII							
KE 8+25	KE-3	Y	Y4-1ØBC	480V	N250	MSIII							
KE 10+23	KE-4	Y	Y4-1ØBC	480V	N250	MSIII							
KE 12+29	KE-5	Y	Y4-1ØBC	480V	N250	MSIII							
KE 14+20	KE-6	Y	Y4-1ØBC	480V	N250	MSIII							
K 108+24	K-7	Y	Y4-2ØCA	480V	N250	MSIII							
FW 57+77	K-8A	Y	Y4-2ØCA	480V	N250	MSIII							
FW 59+37	K-9A	Y	Y4-2ØCA	480V	N250	MSIII							
FW 60+75	K-10A	Y	Y4-1ØCA	480V	N250	MSIII							
FW 63+59	K-12A	Y	Y4-2ØCA	480V	N250	MSIII							

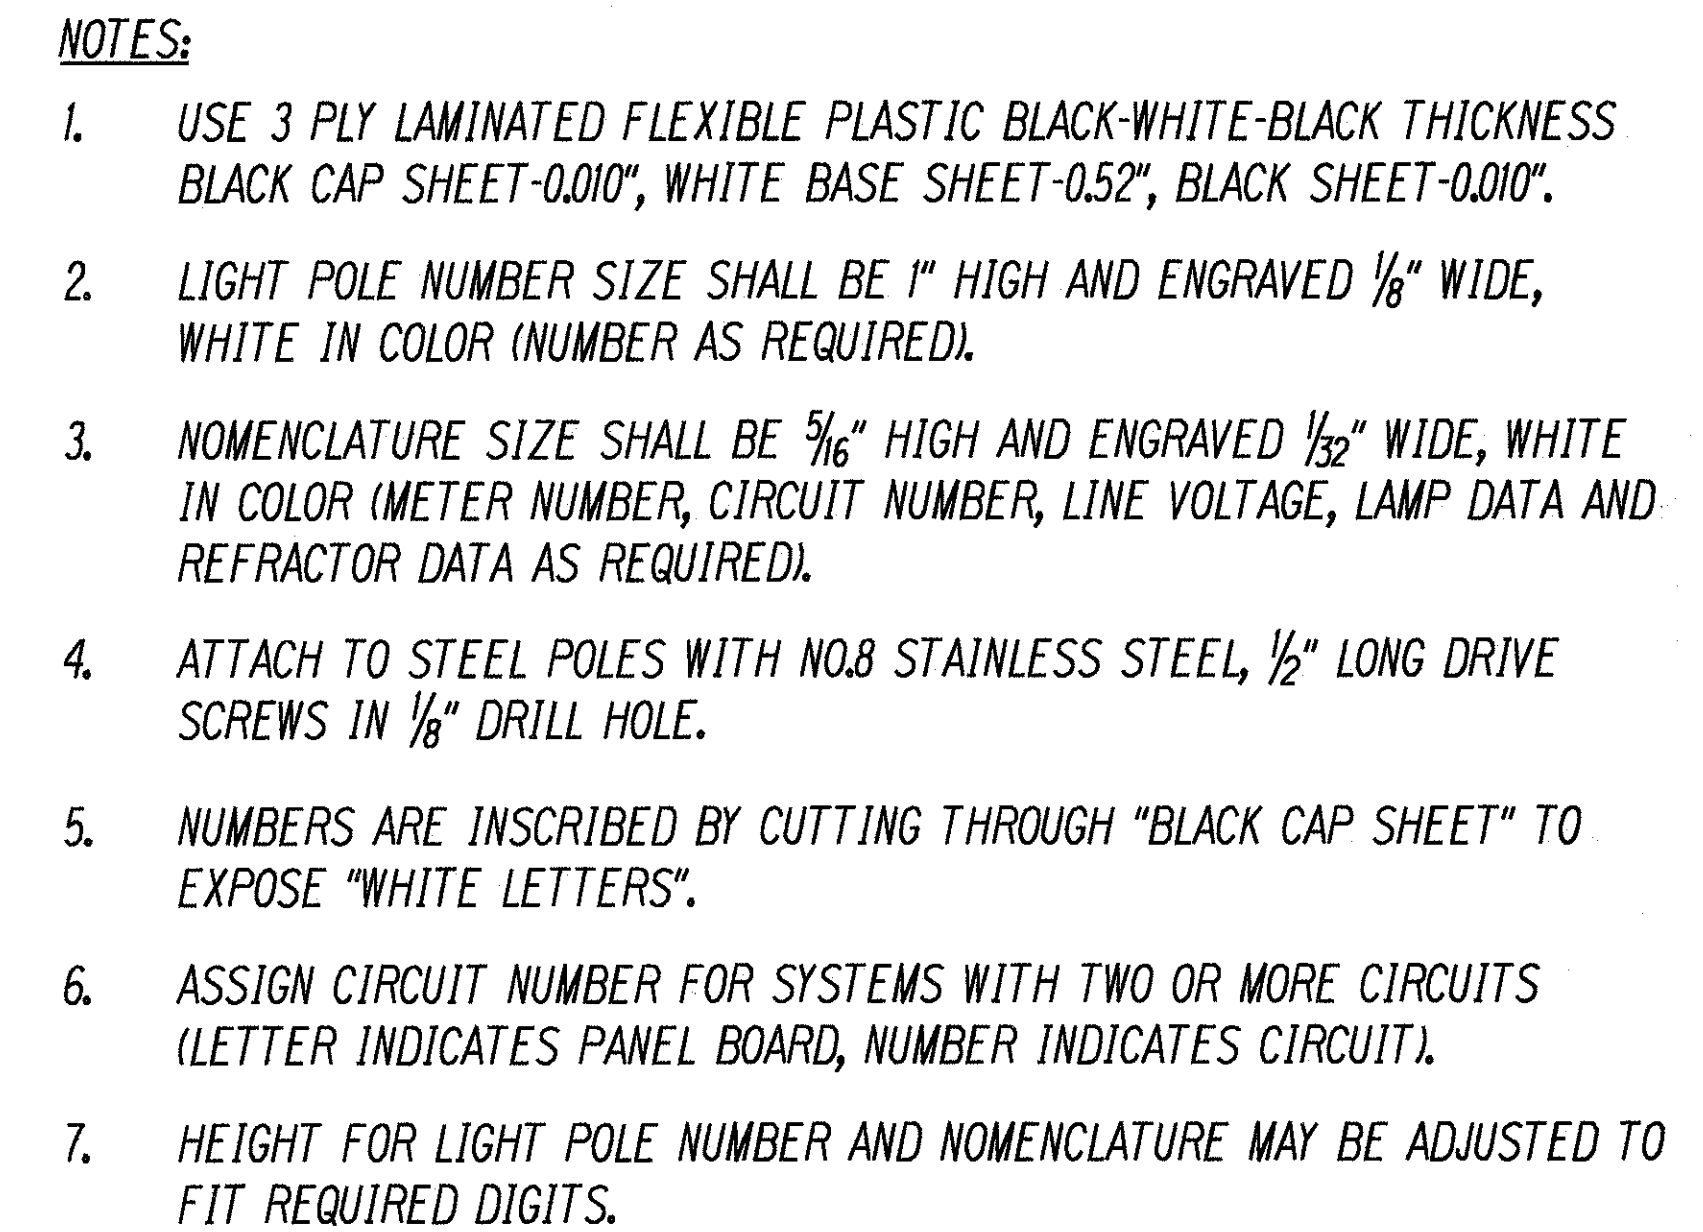

STATE OF HAWAII
DEPARTMENT OF TRANSPORTATION
HIGHWAYS DIVISION

STREET LIGHT ID TAG SCHEDULE - I


INTERSTATE ROUTE H-1
Kunia Interchange Improvements
E.A.J. Project No. 1M-HI-K219

SCALE: AS NOTED DATE: OCT. 1997

SHEET No. E42 OF 43 SHEETS

STREET LIGHT ID TAG SCHEDULE - II													
HIGHWAY LIGHT STA. NUMBER	ID TAG ITEMS						HIGHWAY LIGHT STA. NUMBER	ID TAG ITEMS					
	LIGHT POLE NO.	METER NO.	CIRCUIT NO.	LINE VOLTAGE	LAMP DATA	REFRACTOR DATA		LIGHT POLE NO.	METER NO.	CIRCUIT NO.	LINE VOLTAGE	LAMP DATA	REFRACTOR DATA
H-1 293+10	H-5	Z	Z4-4ØBC	480V	N250	MSIII	HE 18+18	HE-8	Z	Z4-5ØAB	480V	N250	MSIII
H-1 291+00	H-7	Z	Z4-3ØBC	480V	N250	MSIII	HE 20+15	HE-9	Z	Z4-6ØBC	480V	N250	MSIII
H-1 307+49	HK-7A	Z	Z4-1ØAB	480V	N250	MSIII	HE 21+79	HE-10	Z	Z4-5ØBC	480V	N250	MSIII
H-1 309+70	HK-9A	Z	Z4-2ØAB	480V	N250	MSIII	HE 23+17	HE-11	Z	Z4-6ØCA	480V	N250	MSIII
H-1 312+20	HK-11A	Z	Z4-5ØBC	480V	N250	MSIII	HE 25+66	HE-12	Z	Z4-5ØCA	480V	N250	MSIII
H-1 314+71	HK-13A	Z	Z4-6ØBC	480V	N250	MSIII	HE 27+74	HE-13	Z	Z4-6ØAB	480V	N250	MSIII
H-1 317+44	HK-15A	Z	Z4-5ØCA	480V	N250	MSIII	HE 29+46	HE-14	Z	Z4-5ØAB	480V	N250	MSIII
H-1 325+03	HK-21	Z	Z2-2ØAB	240V	N250	MSIII	HE 31+06	HE-15	Z	Z4-6ØBC	480V	N250	MSIII
H-1 327+57	HK-23A	Z	Z2-2ØAB	240V	N250	MSIII	HE 33+19	HE-16	Z	Z4-5ØBC	480V	N250	MSIII
H-1 329+82	HK-25A	Z	Z2-2ØAB	240V	N250	MSIII	KW 22+30	K-1	Z	Z2-2ØAB	240V	N250	MSIII
H-1 331+94	HK-27A	Z	Z2-2ØAB	240V	N250	MSIII	K 101+15	K-2	Z	Z2-2ØAB	240V	N250	MSIII
H-1 334+02	HK-28B	Z	Z2-2ØAB	240V	N250	MSIII	K 102+45	K-3	Z	Z2-1ØAB	240V	N250	MSIII
H-1 336+10	HK-29A	Z	Z2-2ØAB	240V	N250	MSIII	K 103+95	K-4	Z	Z2-2ØAB	240V	N250	MSIII
H-1 338+20	HK-31	Z	Z2-2ØAB	240V	N250	MSIII	K 105+92	K-6	Z	Z2-2ØAB	240V	N250	MSIII
H-1 341+95	HK-33	Z	Z2-2ØAB	240V	N250	MSIII	KW 20+85	KC-1	Z	Z2-1ØBC	240V	N250	MSIII
H-1 344+84	HK-35	Z	Z2-2ØAB	240V	N250	MSIII	KW 21+20	KC-2	Z	Z2-1ØBC	240V	N250	MSIII
EW 1+13	EW-1	Z	Z4-2ØBC	480V	N250	MSIII	K 101+25	KC-2A	Z	Z2-1ØBC	240V	N250	MSIII
EW 3+26	EW-2	Z	Z4-1ØBC	480V	N250	MSIII	KO 0+85	KD-1	Z	Z2-2ØAB	240V	N250	MSIII
EW 5+28	EW-3	Z	Z4-2ØAB	480V	N250	MSIII	KO 2+81	KD-2	Z	Z2-2ØAB	240V	N250	MSIII
EW 7+25	EW-4	Z	Z4-1ØAB	480V	N250	MSIII	KO 4+85	KD-3	Z	Z2-2ØAB	240V	N250	MSIII
EW 9+25	EW-5	Z	Z4-2ØCA	480V	N250	MSIII	KO 6+84	KD-4	Z	Z2-2ØAB	240V	N250	MSIII
EW 11+25	EW-6	Z	Z4-1ØCA	480V	N250	MSIII	KO 8+86	KD-5	Z	Z2-2ØAB	240V	N250	MSIII
EW 14+00	EW-7	Z	Z4-2ØBC	480V	N250	MSIII	KO 10+90	KD-6	Z	Z2-2ØAB	240V	N250	MSIII
EW 16+00	EW-8	Z	Z4-1ØBC	480V	N250	MSIII	KO 12+85	KD-7	Z	Z2-2ØAB	240V	N250	MSIII
EW 18+10	EW-9	Z	Z4-2ØAB	480V	N250	MSIII	KO 15+15	KD-8	Z	Z2-2ØAB	240V	N250	MSIII
EW 20+10	EW-10	Z	Z4-1ØAB	480V	N250	MSIII	KW 20+85	KC-1	Z	Z2-1ØBC	240V	N250	MSIII
EW 22+10	EW-11	Z	Z4-2ØCA	480V	N250	MSIII	KW 21+20	KC-2	Z	Z2-1ØBC	240V	N250	MSIII
EW 24+08	EW-12	Z	Z4-1ØCA	480V	N250	MSIII	K 101+25	KC-2A	Z	Z2-1ØBC	240V	N250	MSIII
EW 26+05	EW-13	Z	Z4-2ØBC	480V	N250	MSIII	K 102+45	K-3	Z	Z2-1ØBC	240V	N250	MSIII
EW 28+02	EW-14	Z	Z4-1ØBC	480V	N250	MSIII							
EW 30+02	EW-15	Z	Z4-2ØAB	480V	N250	MSIII							
EW 32+00	EW-16	Z	Z4-1ØAB	480V	N250	MSIII							
HE 0+65	HE-1	Z	Z4-6ØAB	480V	N250	MSIII							
HE 6+29	HE-2	Z	Z4-5ØAB	480V	N250	MSIII							
HE 8+23	HE-3	Z	Z4-6ØBC	480V	N250	MSIII							
HE 10+23	HE-4	Z	Z4-5ØBC	480V	N250	MSIII							
HE 12+26	HE-5	Z	Z4-6ØCA	480V	N250	MSIII							
HE 14+26	HE-6	Z	Z4-5ØCA	480V	N250	MSIII							
HE 16+20	HE-7	Z	Z4-6ØAB	480V	N250	MSIII							

 LAST SAVE: 10/07/97 @ 13:32:28 BY: GN PLOT SC F-0-M



SCALE: AS NOTED DATE: OCT. 1997

SHEET No. E43 OF 43 SHEETS