
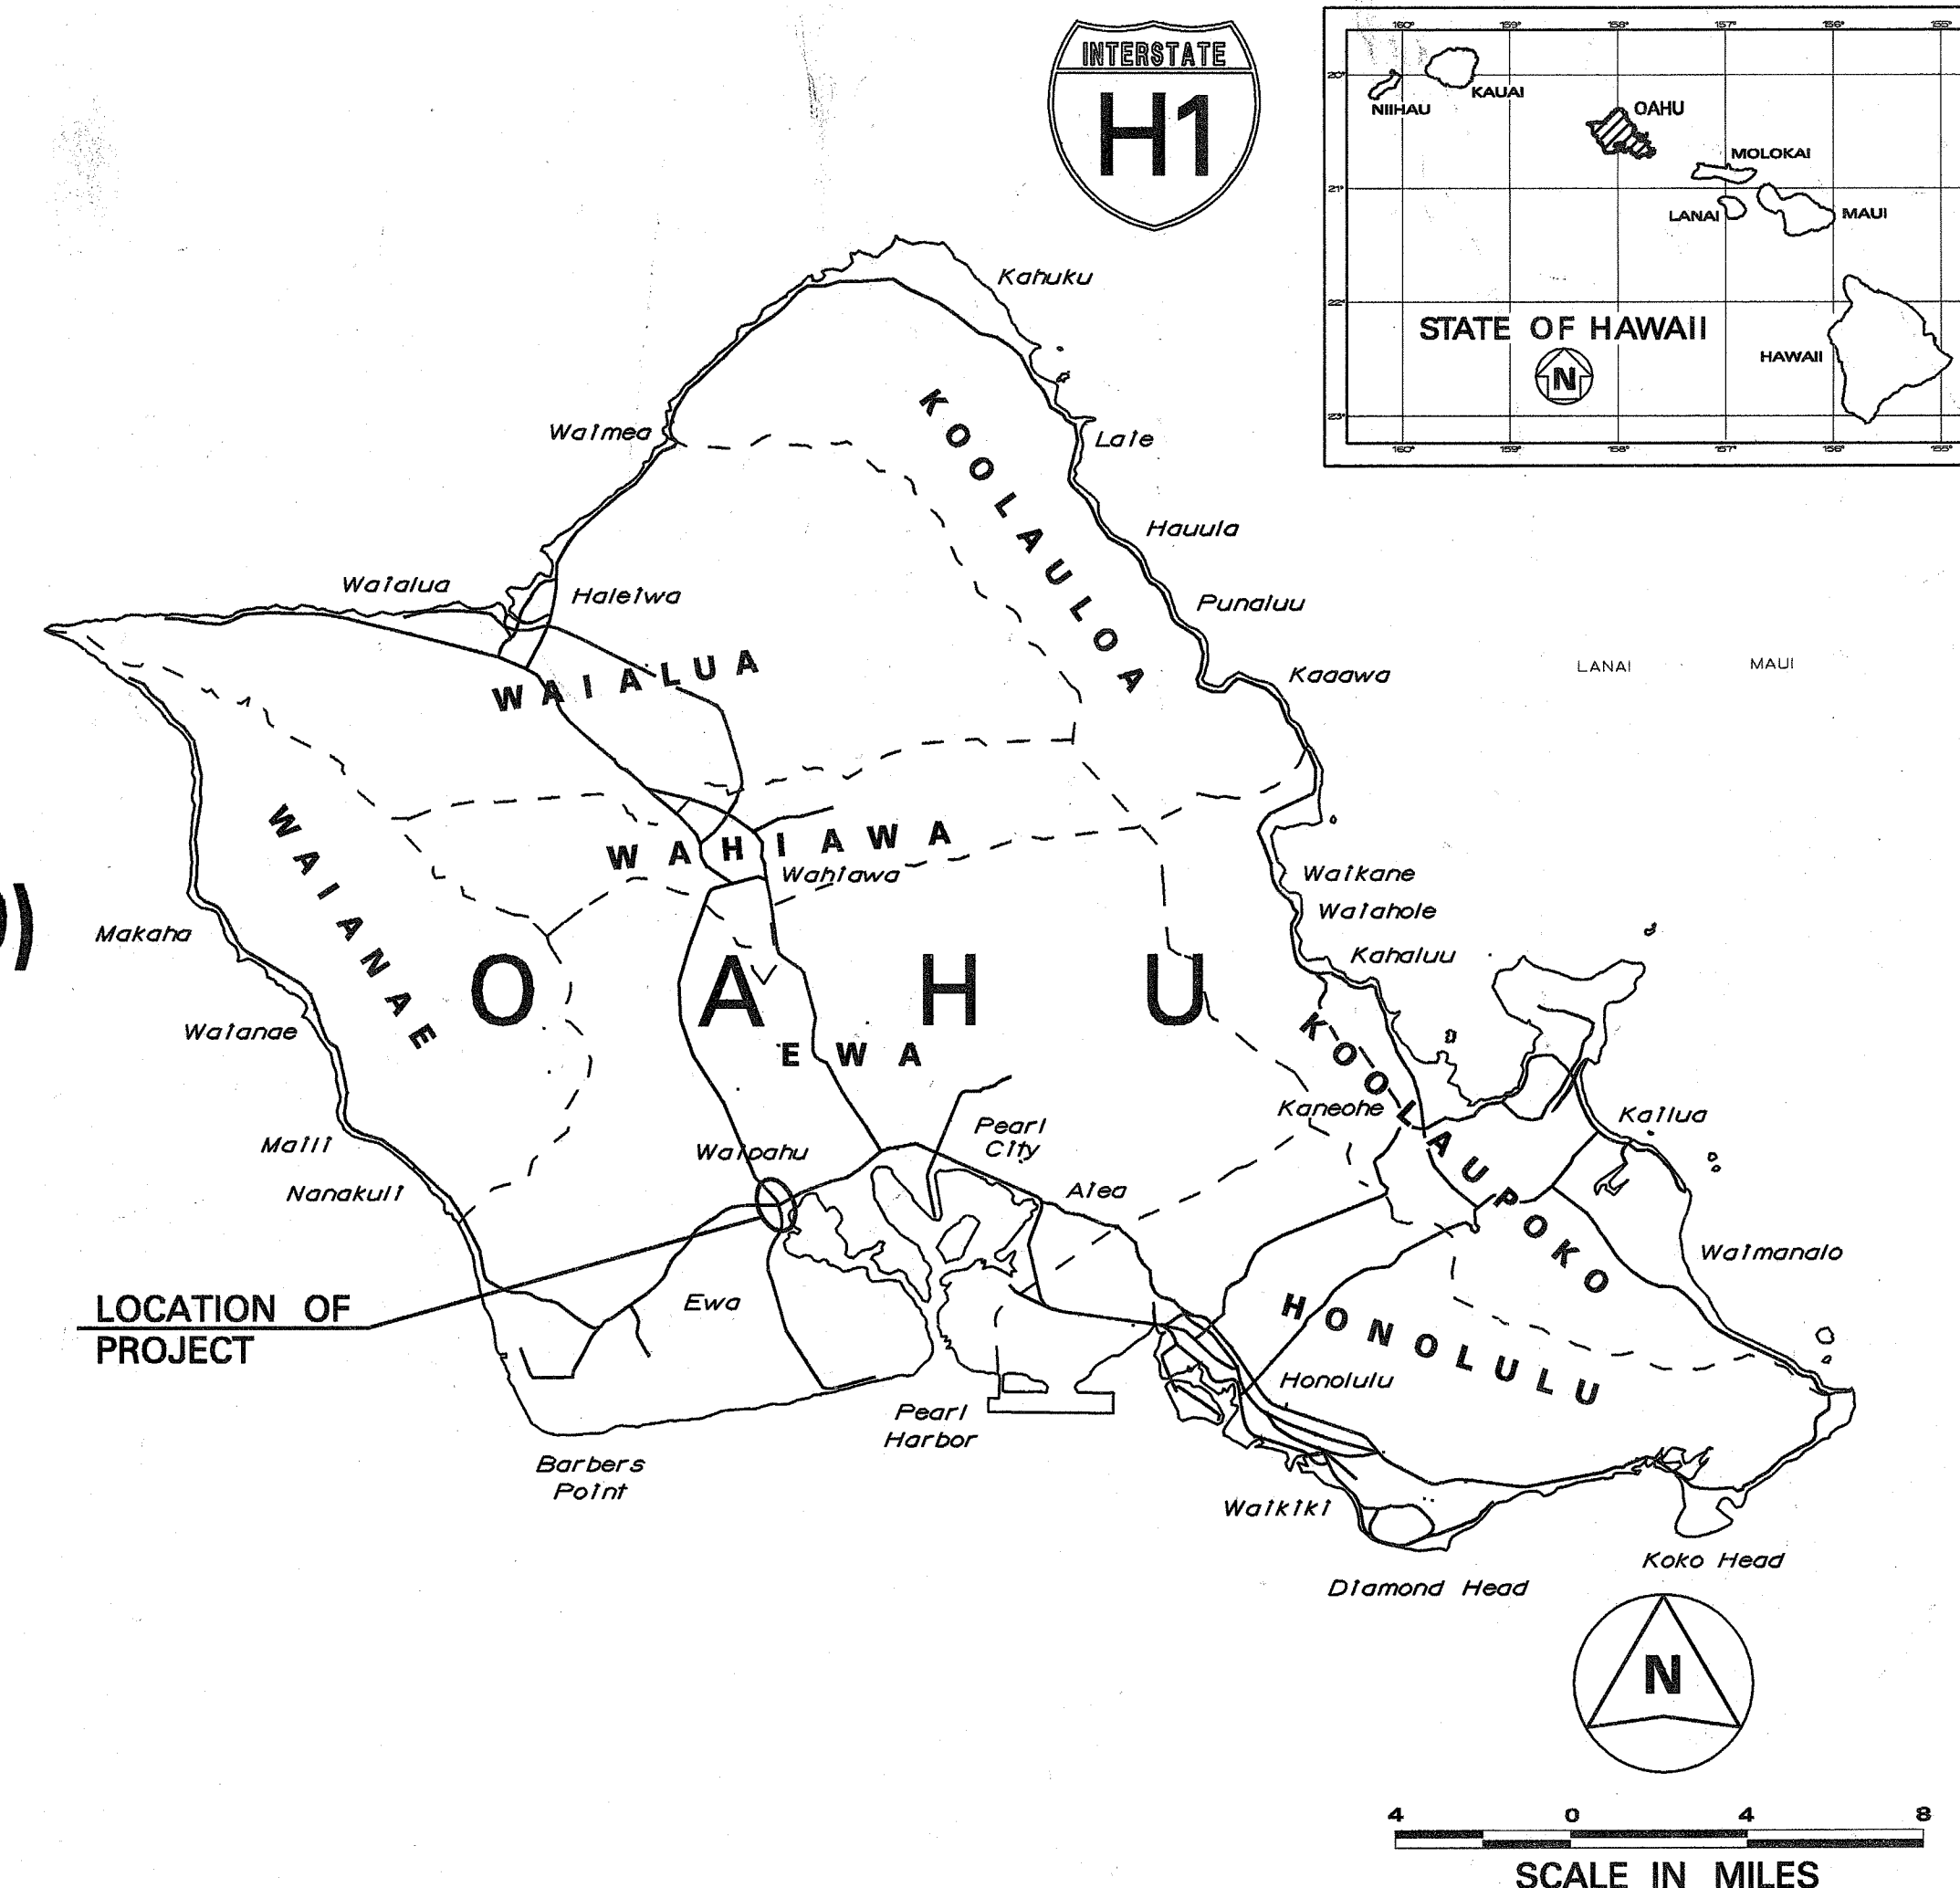


INDEX TO DRAWINGS	
SHEET NO.	DESCRIPTION
1	TITLE SHEET
2	STANDARD PLANS SUMMARY
3	GENERAL NOTES
4	NPDES GENERAL NOTES
5	LEGEND AND ABBREVIATIONS
6 - 28	TYPICAL SECTIONS AND MISC. DETAILS
29	ROADWAY & ALIGN. PLANS KEY MAP
30 - 40	ALIGNMENT PLANS
41 - 46	SUPERELEVATION DIAGRAMS
47 - 52	PROFILES
53 - 57	PAVEMENT GRADE PLANS
58 - 68	ROADWAY PLANS
69 - 109	CONSTRUCTION PHASING NOTES, LEGEND & PLANS
110 - 139	RETAINING WALLS & MISC. DETAILS
140 - 195	DRAINAGE SUMMARY, PLANS, PROFILE & DETAILS
196 - 221	PAVEMENT MARKING & SIGNING PLANS, DETAILS & NOTES
222 - 264	ELECTRICAL & HIGHWAY LIGHTING PLANS
265 - 316	LANDSCAPING PLANS
317 - 375	CROSS SECTIONS
376 - 378	BORING LOGS

STATE OF HAWAII
DEPARTMENT OF TRANSPORTATION
HIGHWAYS DIVISION
HONOLULU, HAWAII
"AS-BUILT"
PLANS FOR
INTERSTATE ROUTE H-1
KUNIA INTERCHANGE IMPROVEMENTS
FEDERAL AID INTERSTATE PROJECT NO. IM-H1-1(219)
DISTRICT OF EWA
ISLAND OF OAHU

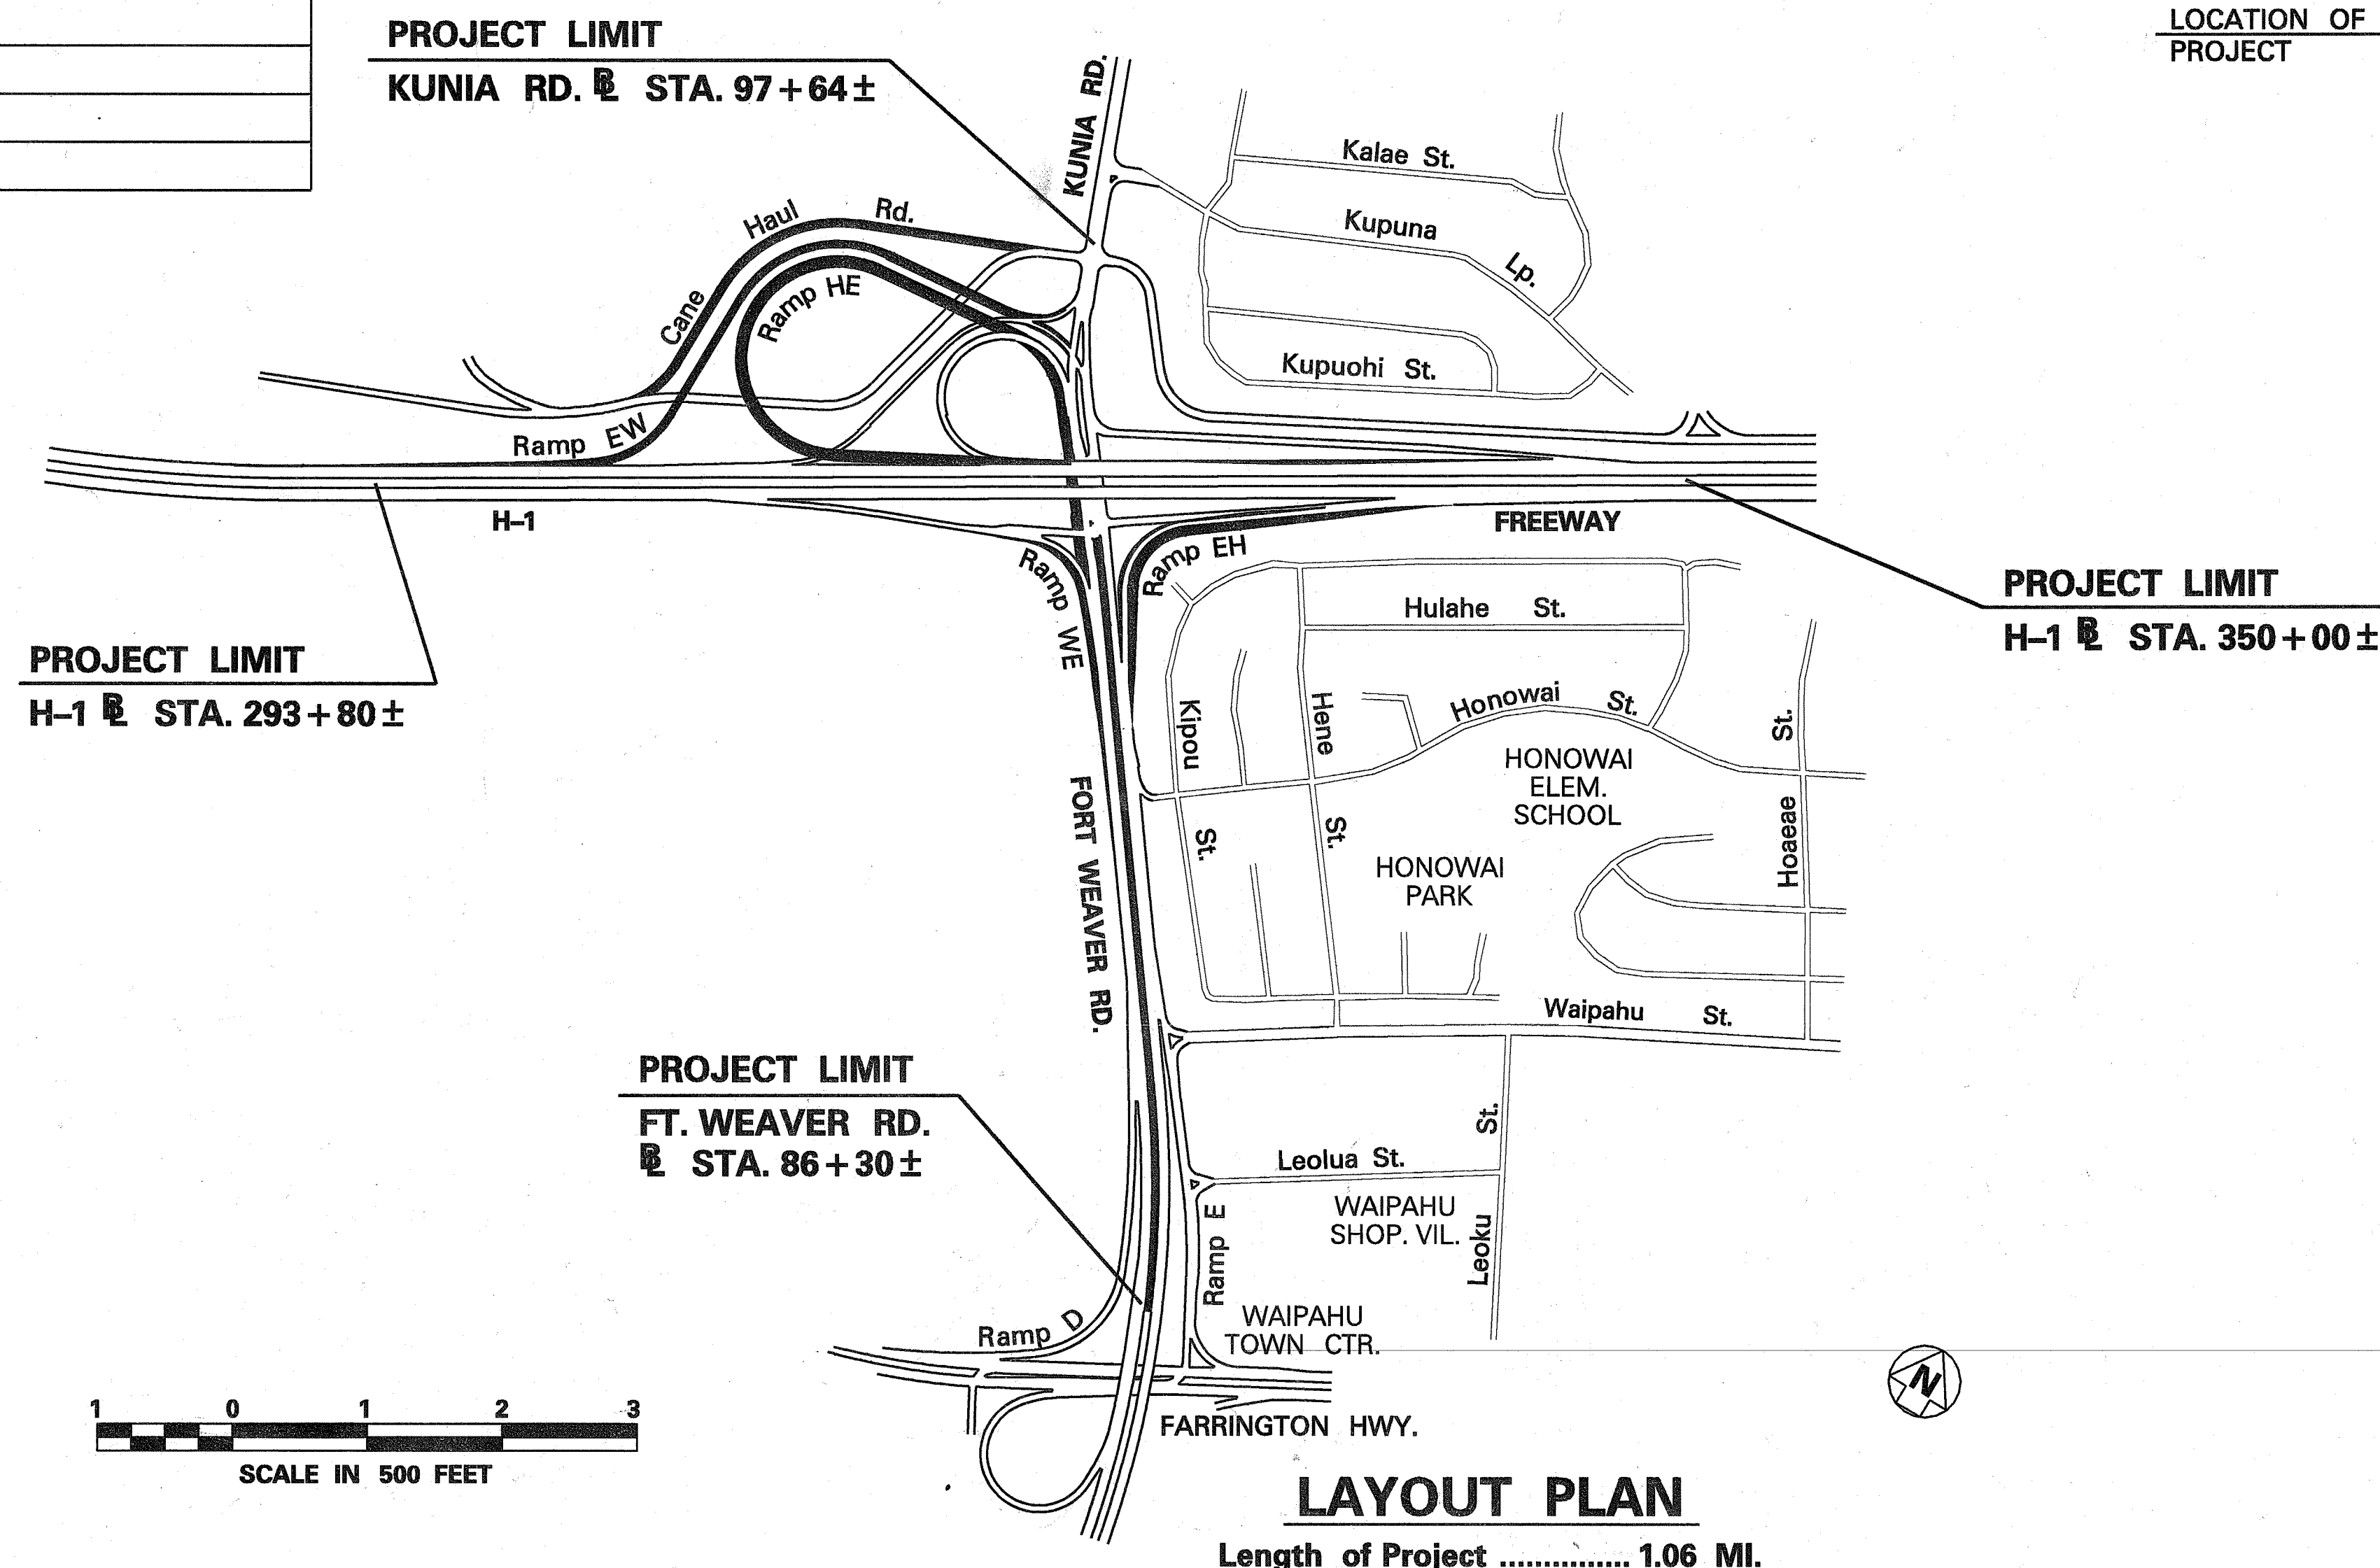

FED. ROAD DIST. NO.	STATE	FED. AID PROJ. NO.	FISCAL YEAR	SHEET NO.	TOTAL SHEETS
HAWAII	HAW.	IM-H1-1(219)	1998	1	378

DESIGN DESIGNATION	
ADT (1997)	121,910
ADT (2007)	180,210
DHV	14,800
T24	6.5 %
V	70 M.P.H.

CHANGES MADE DURING CONSTRUCTION HAVE BEEN INCORPORATED ON THESE PLANS EXCEPT CHANGES IN THE ORIGINAL THEORETICAL QUANTITIES. FOR ACTUAL QUANTITIES, REFER TO PROJECT LEDGER AND/OR COMPUTATION BOOK.

Wahne C. Lau 05/26/09
RESIDENT ENGINEER DATE

DEPARTMENT OF TRANSPORTATION
STATE OF HAWAII
APPROVED: *Kay H. Hays* 11/13/97
DIR. OF TRANSPORTATION DATE

HWY-DD UNIT 'A' DESIGNED BY JULIUS FRONDA P.S. & E. BY OCT. 1997 DATE 587-2246 PHONE

LAYOUT PLAN
Length of Project 1.06 MI.