
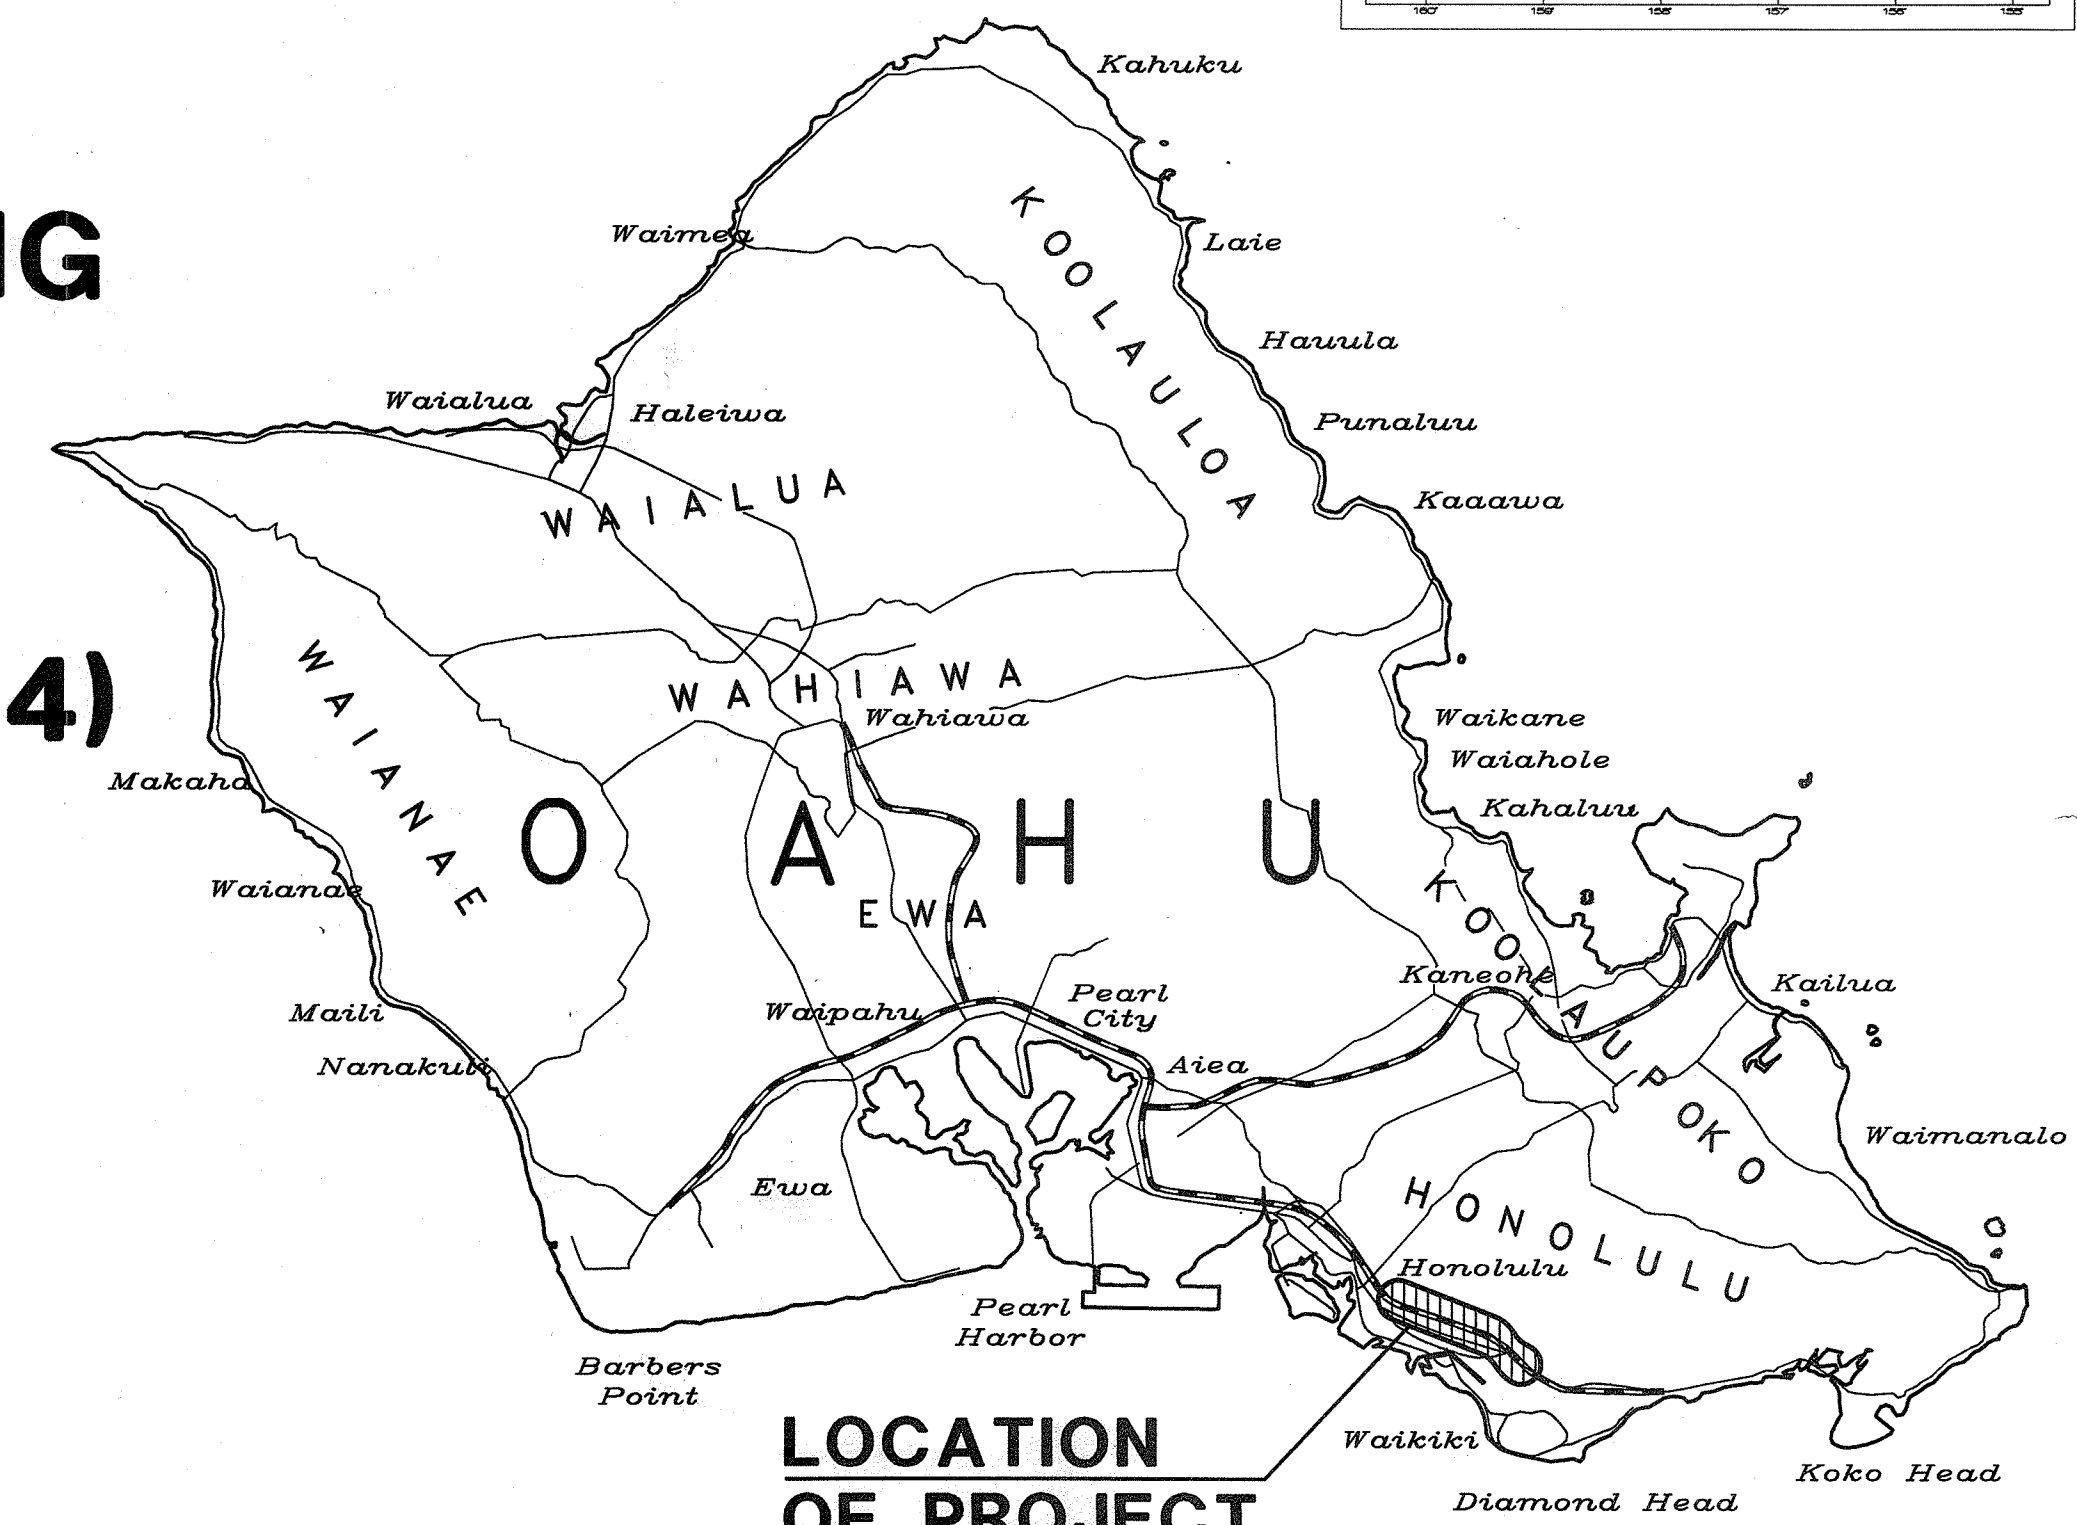



INDEX TO DRAWINGS	
SHEET NO.	DESCRIPTION
1	TITLE SHEET
2	STANDARD PLANS SUMMARY
3	NPDES GENERAL NOTES
4 - 5	GENERAL NOTES, LEGEND AND ABBREVIATIONS
6 - 21	TYPICAL SECTIONS
22 - 25	WEAKENED PAVEMENT DETAILS AND SCHEDULES
26 - 28	GENERAL PLANS
29 - 52	ROADWAY PLANS
53 - 55	GUARD RAIL DETAILS/SUMMARY (SHT. 54 DELETED; INCL. SHT. 55S-1 TO 55S-14)
56 - 61	IMPACT ATTENUATOR DETAILS AND SCHEDULE
62	STREET MONUMENT SCHEDULES
63 - 116	DETAILED ROADWAY PLANS
117 - 120	CURB RAMP DETAILS
121 - 155	PAVEMENT MARKING AND SIGNING PLANS/DETAILS
156 - 161	CONSTRUCTION PHASING PLANS
162 - 269	TRAFFIC CONTROL PLANS, NOTES, AND DETAILS
270 - 272	TRAFFIC SUMMARIES
273 - 282	CROSS SECTION KEY MAP/CROSS SECTIONS
283 - 398	BRIDGE RAIL/MEDIAN BARRIER UPGRADES (INCL. SHT. 354S-1, 385S-1 AND 395S-1)
399 - 443	HIGHWAY LIGHTING PLANS/DETAILS
444 - 456	TRAFFIC SIGNAL PLANS/DETAILS (INCL. SHT. 449S-1, 452S-1 AND 452S-2)
457 - 478	PUNAHOU PUMP STATION
479 - 557	WATER PLANS, NOTES AND DETAILS (INCL. SHT. 480S-1 AND 482S-1)

STATE OF HAWAII
DEPARTMENT OF TRANSPORTATION
HIGHWAYS DIVISION
HONOLULU, HAWAII
"AS-BUILT"
PLANS FOR
INTERSTATE ROUTE H-1 RESURFACING
VICINITY OF PUNCHBOWL OFF-RAMP
TO KAPIOLANI INTERCHANGE
FEDERAL AID PROJECT NO. IM-H1-1(234)
DISTRICT OF HONOLULU
ISLAND OF OAHU

FED. ROAD DIST. NO.	STATE	FED. AID PROJ. NO.	FISCAL YEAR	SHEET NO.	TOTAL SHEETS
HAWAII	HAW.	IM-H1-1(234)	2000	1	557

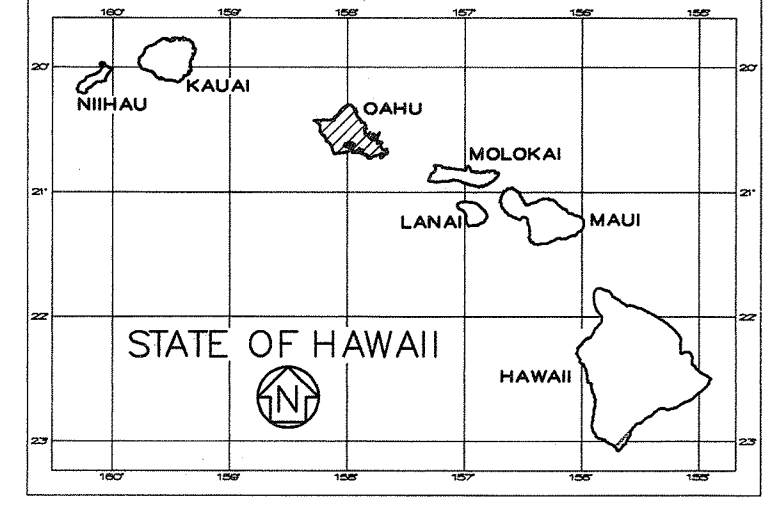

LOCATION OF PROJECT

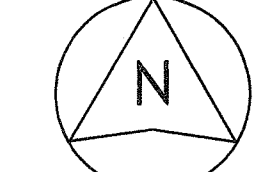

SCALE IN MILES

CHANGES MADE DURING CONSTRUCTION HAVE BEEN INDICATED ON THESE PLANS EXCEPT CHANGES IN THE ORIGINAL THEORETICAL QUANTITIES. FOR ANY ADDITIONAL DATA TO PROJECT LOGBOOK, REFER TO THE PROJECT LOGBOOK.

MILE POST 22.48 TO MILE POST 25.24

FEDERAL AID INTERSTATE PROJECTS PREVIOUSLY CONSTRUCTED OR UNDER CONSTRUCTION



DESIGN DESIGNATION

ADT (1999)	180,900
ADT (2009)	195,100
DHV	13,600
D	55/45
T24	2.0 %
V	50 M.P.H.



GENERAL LOCATION PLAN

NET LENGTH OF PROJECT..... 2.76 MILES
GROSS LENGTH OF PROJECT..... 3.13 MILES

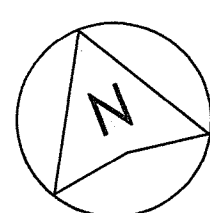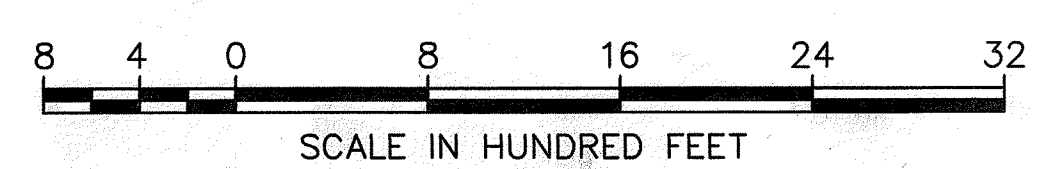

BOARD OF WATER SUPPLY CITY AND COUNTY OF HONOLULU	DEPARTMENT OF TRANSPORTATION STATE OF HAWAII
APPROVED: <i>[Signature]</i> MANAGER & CHIEF ENGINEER	APPROVED: <i>[Signature]</i> DIR. OF TRANSPORTATION
DATE	DATE

HAWAII PACIFIC ENGINEERS
DESIGNED BY
JADINE URASAKI
P. S. & E. BY
587-2630
JUNE 1999
DATE
REVISED: 07/07/99

DATE: 6/5/98
SCALE: 1"=1'
FILE: 9815-01