


INDEX TO DRAWINGS	
SHT. NO.	DESCRIPTION
69	TITLE SHEET
70	STANDARD PLAN SUMMARY
71	GENERAL NOTES AND COLD PLANING NOTES
72	WATER POLLUTION & EROSION CONTROL NOTES
73	HECO NOTES AND LEGEND
74 - 78	TYPICAL PAVEMENT SECTIONS
79	GENERAL PLAN
80 - 84	ROADWAY PLANS
85 - 90	GUARDRAIL DETAILS
91 - 92	IMPACT ATTENUATOR DETAILS
① 93 - 95	MISCELLANEOUS DETAILS
96 - 97	CONCRETE CHANNEL DETAILS
98 - 100	CONCRETE BARRIER DETAILS
101	LOOP DETECTOR DETAILS
102	OVERHEAD SIGNS
103	PAVEMENT MARKING LEGEND DETAILS AND NOTES
104 - 108	PAVEMENT MARKING AND SIGNING PLANS
109 - 113	CONSTRUCTION PHASING PLANS
114 - 115	EROSION CONTROL PLANS
116 - 117	MISCELLANEOUS DETAILS
118 - 120	LIGHT STANDARD CONNECTION DETAILS
121	ADA CONCRETE PAD
122 - 128	BORING LOGS
129	ELECTRICAL SYMBOLS, ELECTRICAL KEY PLAN
130	HIGHWAY LIGHTING NOTES, GENERAL NOTES
131 - 139	ELECTRICAL PLAN
140 - 141	ONE LINE DIAGRAM
142	MISCELLANEOUS DIAGRAMS
143	EXISTING SUBSTA. NO. 1 ELECTRICAL PLAN
144 - 149	DETAILS
150	VEHICLE DETECTOR SYSTEM
151 - 156	LANDSCAPE IRRIGATION
157 - 161	LANDSCAPE PLANTING
162	LANDSCAPE IRRIGATION LEGEND NOTES & DETAILS
163	LANDSCAPE PLANTING DETAILS

Sheet No. ① C.O. ADD 93S-1 is a Supplementary Sheet to this project. Total sheet count after AS-BUILT posting 164 sheets.

STATE OF HAWAII
DEPARTMENT OF TRANSPORTATION
HIGHWAYS DIVISION
HONOLULU, HAWAII
"AS-BUILT"
PLANS FOR
**INTERSTATE ROUTE H-1
REHABILITATION**
OLA LANE TO KALIHI STREET
PROJECT NO. H1H-01-00M
DISTRICT OF HONOLULU
ISLAND OF OAHU


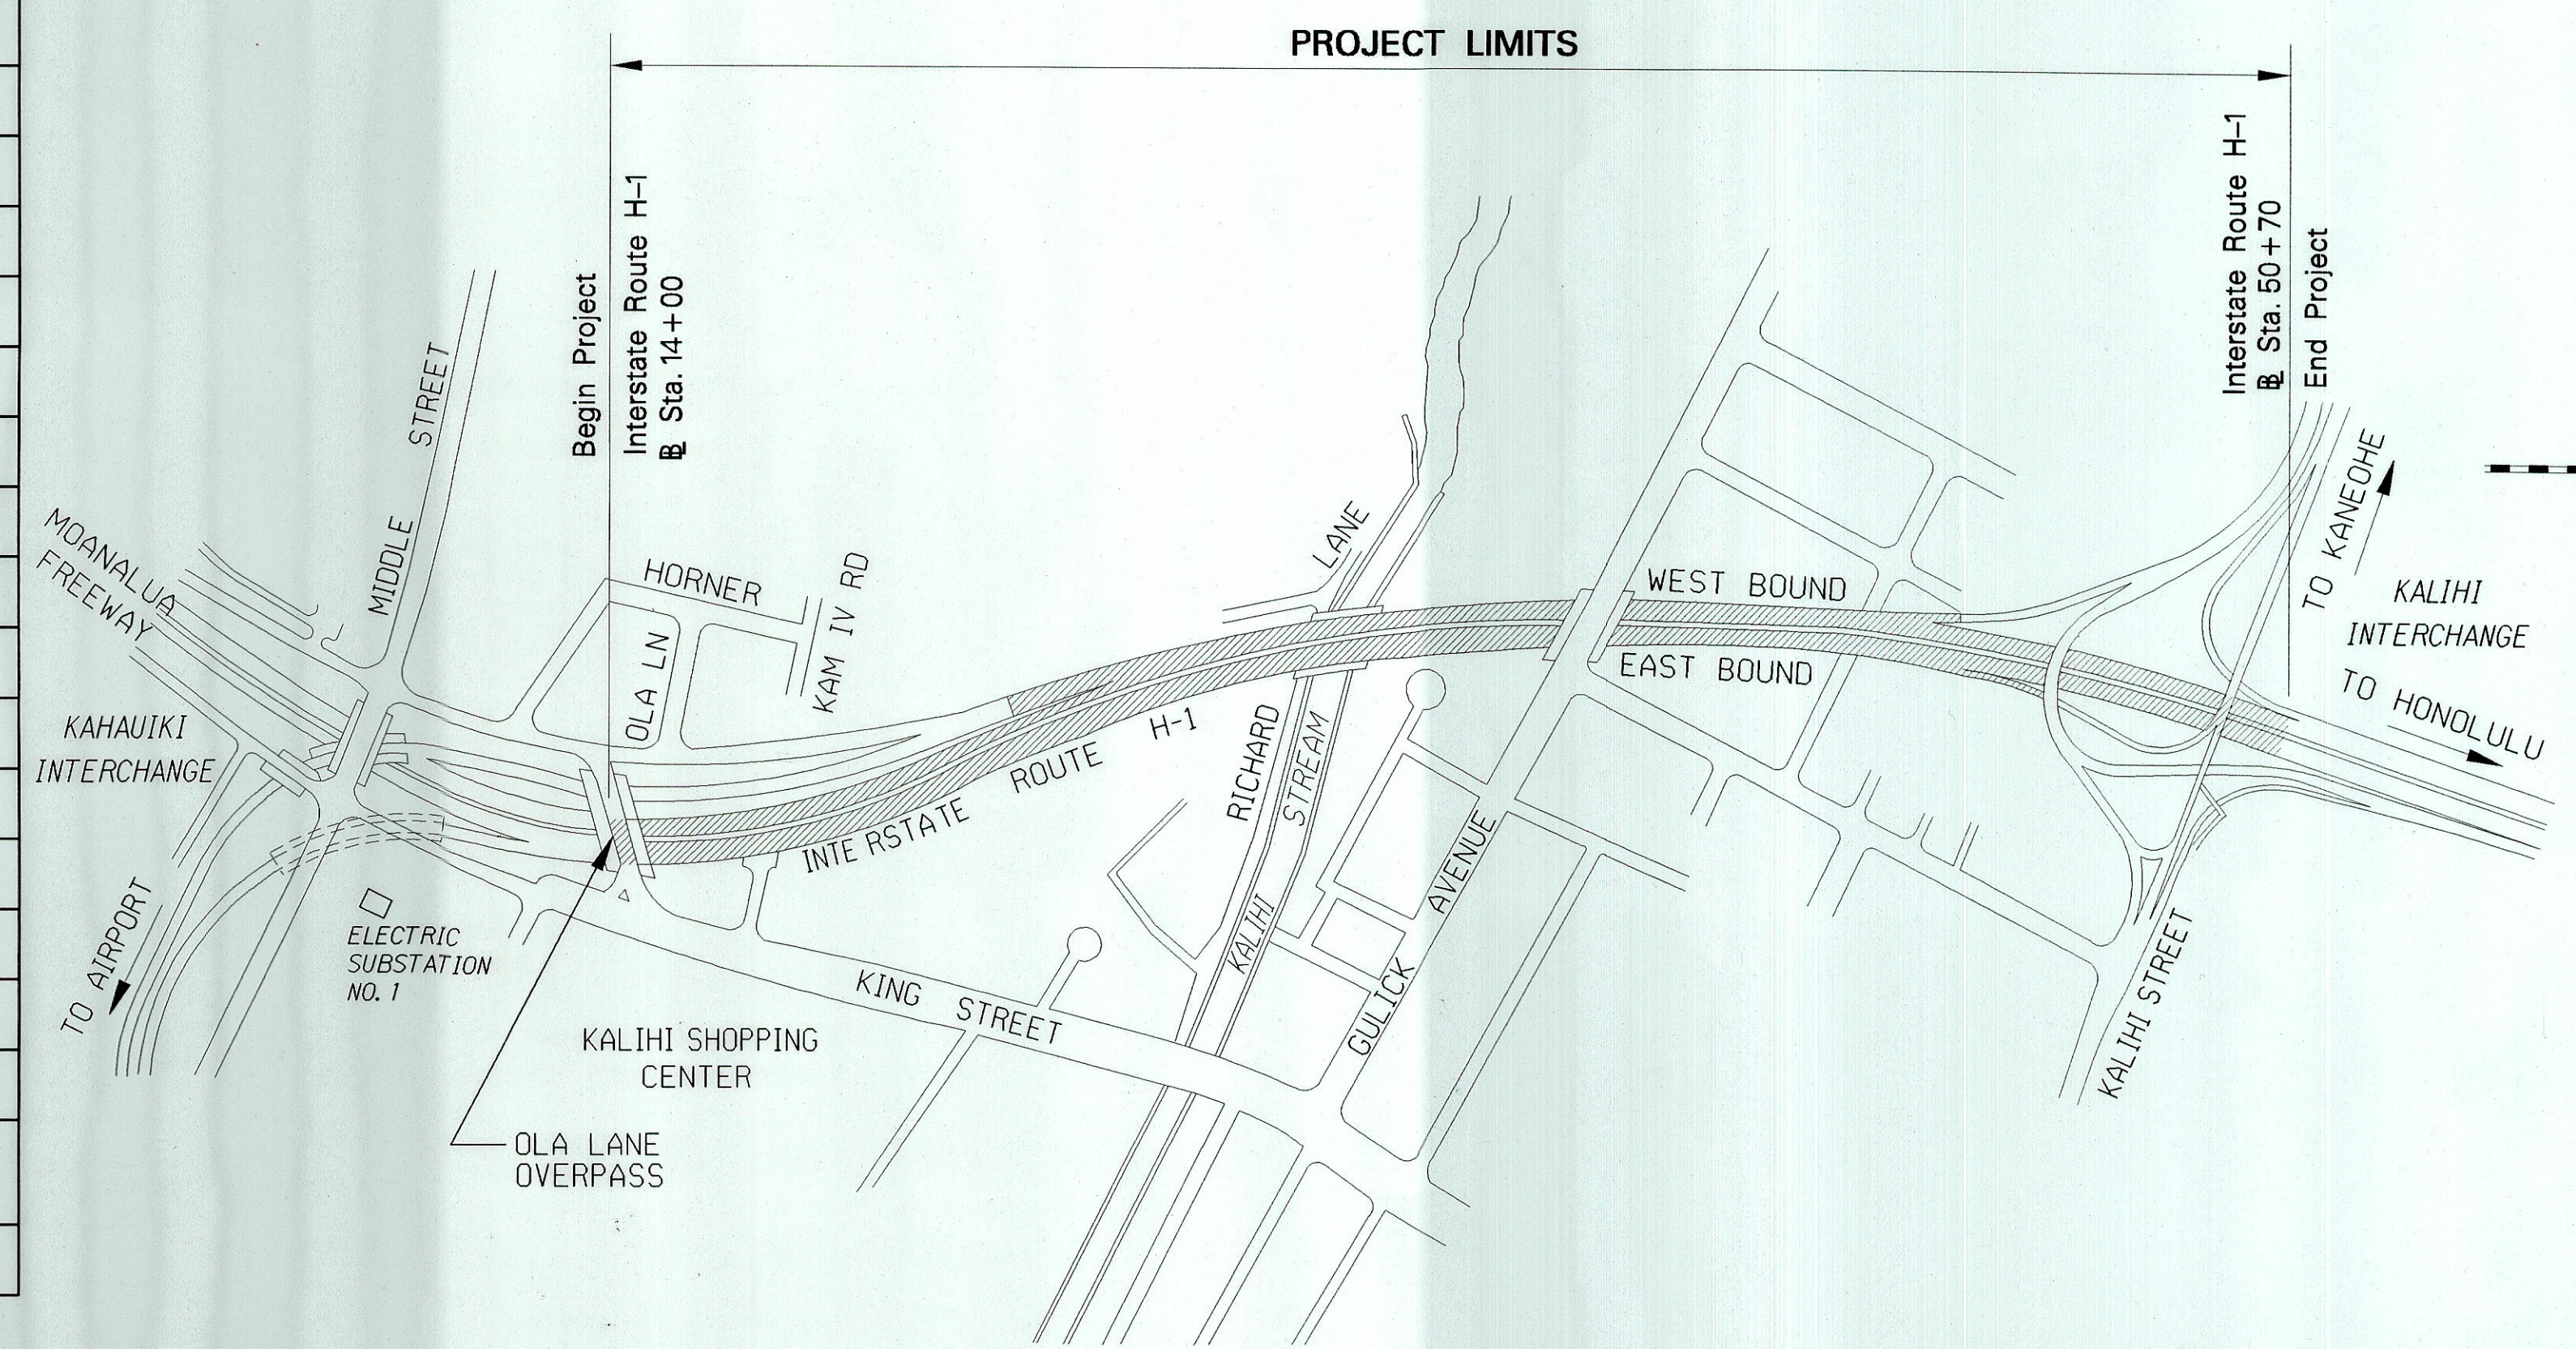


LAYOUT PLAN


NOT TO SCALE

NET LENGTH OF PROJECT 0.65 MILE

FED. ROAD DIST. NO.	STATE	PROJ. NO.	FISCAL YEAR	SHEET NO.	TOTAL SHEETS
HAWAII	HAW.	H1H-01-00M	2003	69	234

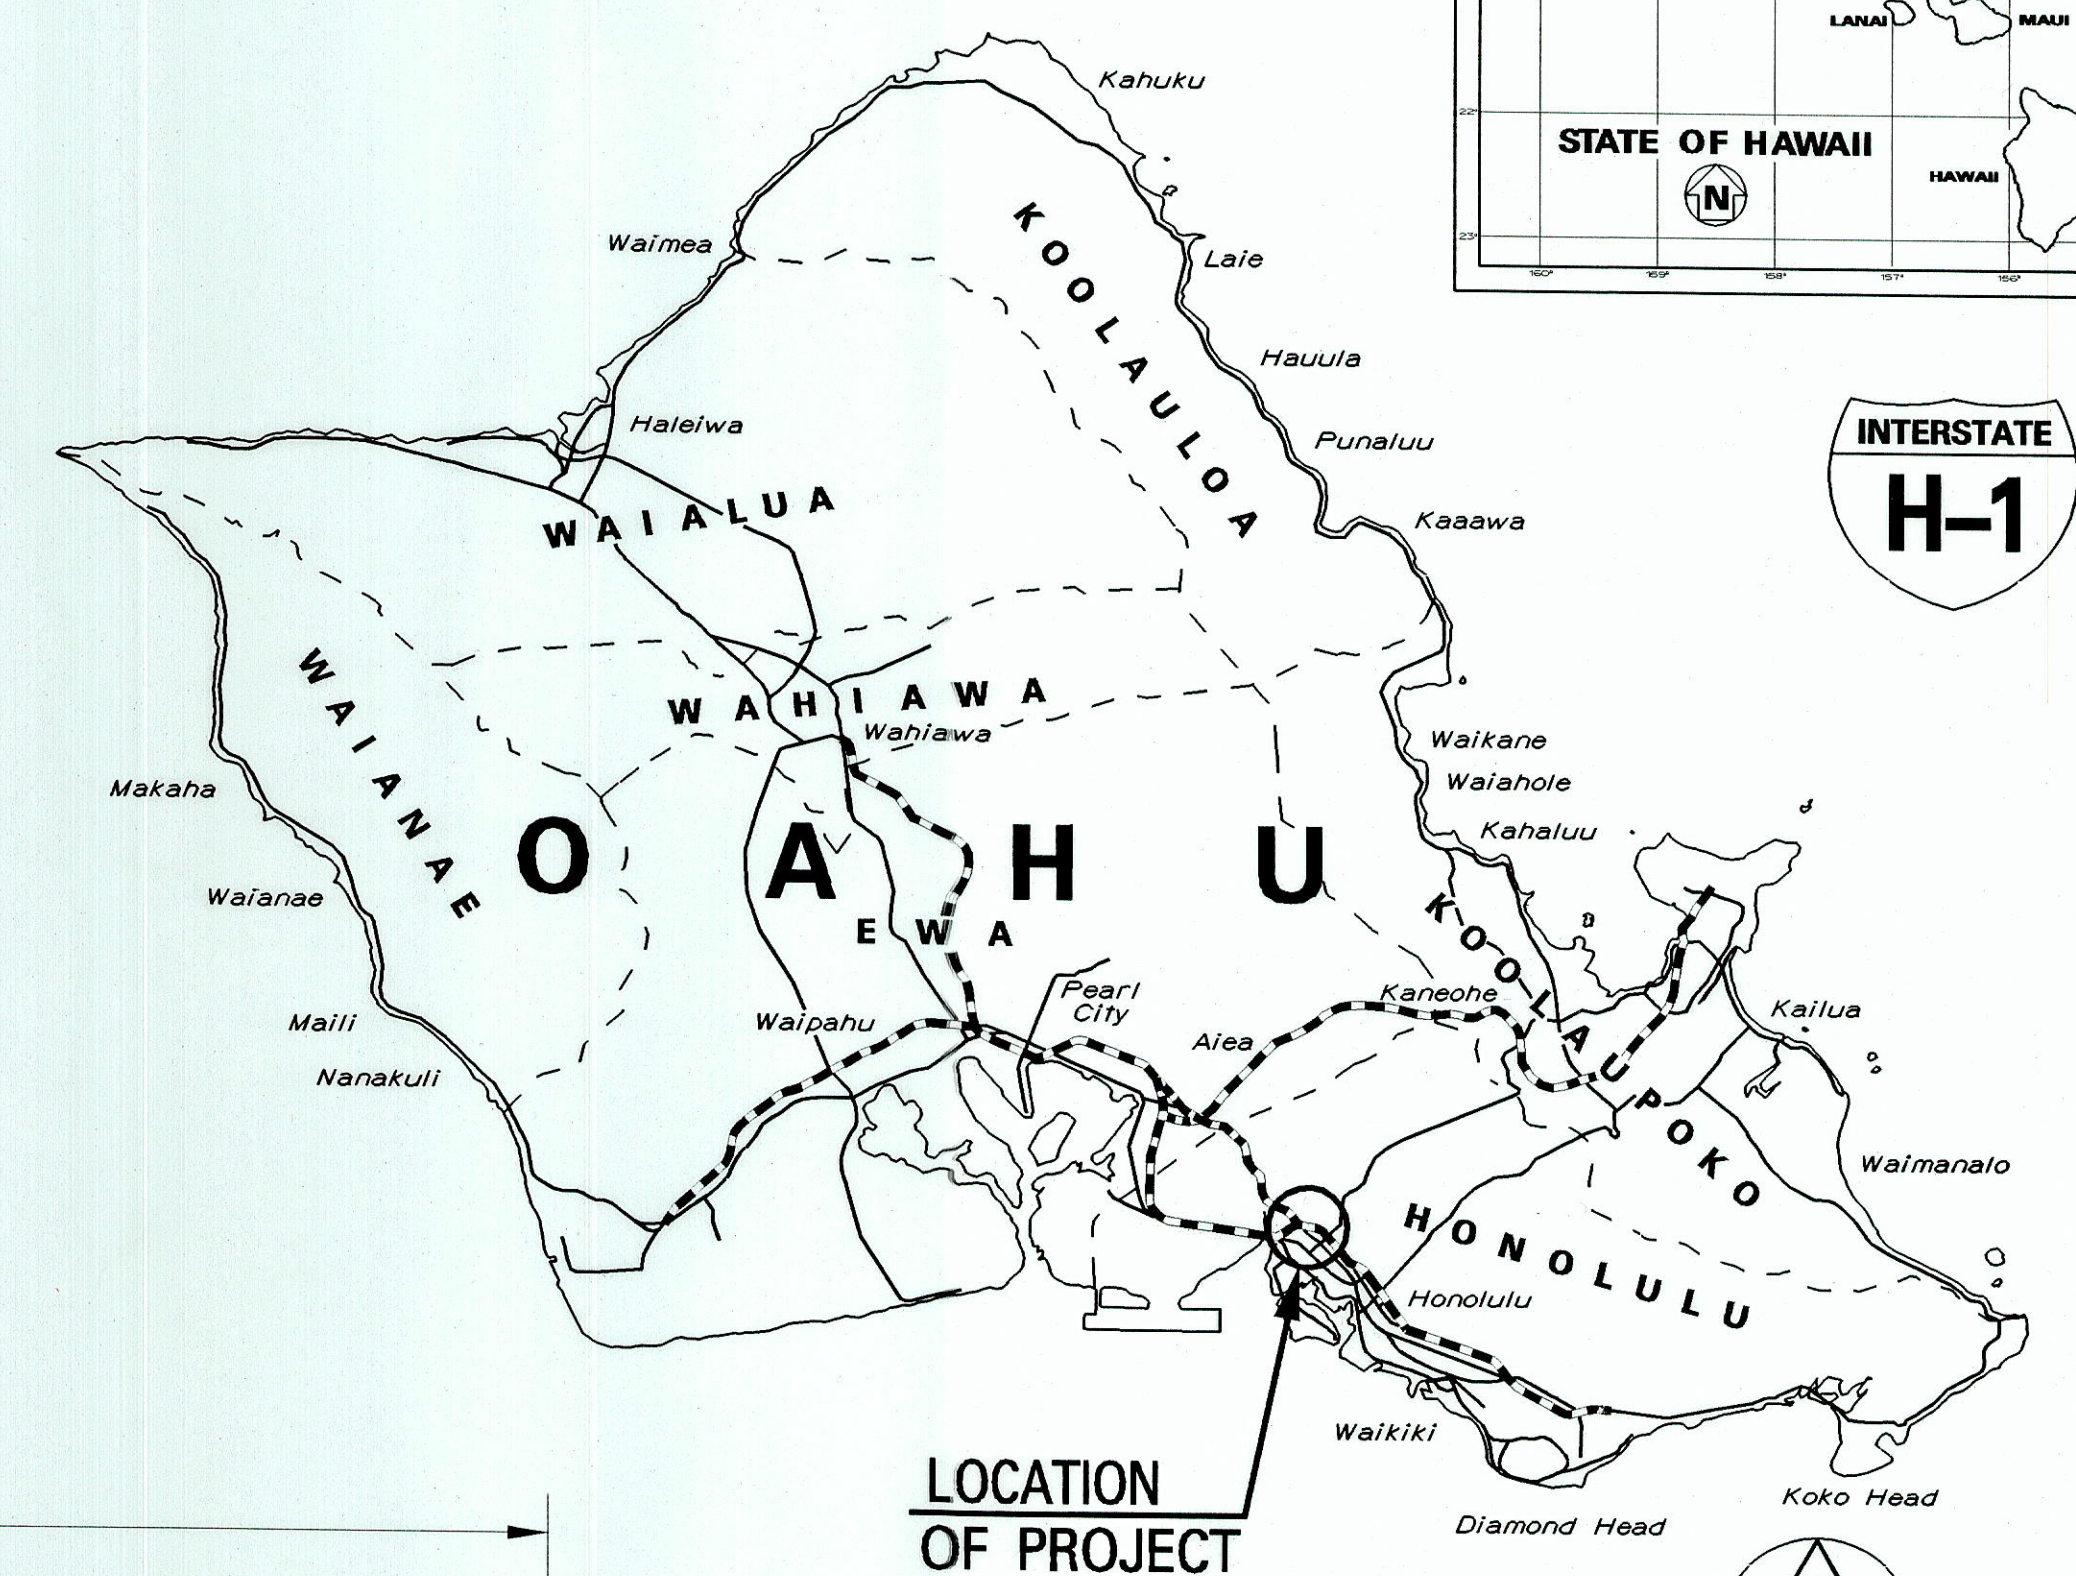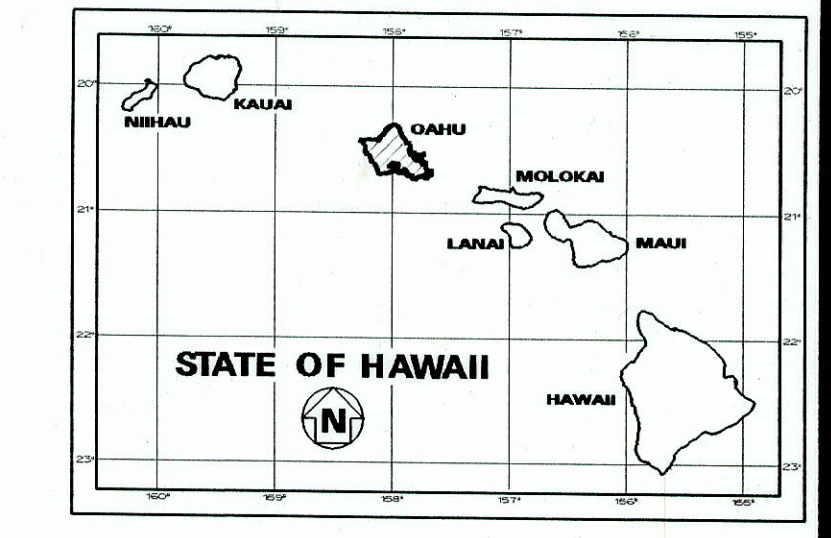

LOCATION OF PROJECT

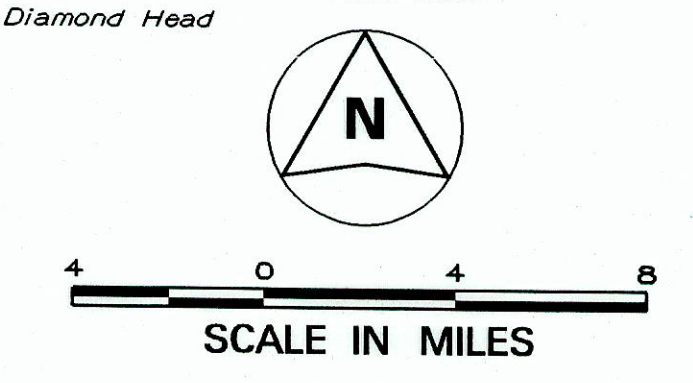

----- FEDERAL AID INTERSTATE PROJECTS PREVIOUSLY CONSTRUCTED OR UNDER CONSTRUCTION

MILE POST 18.97 TO MILE POST 19.62

CHANGES MADE DURING CONSTRUCTION HAVE BEEN INCORPORATED ON THESE PLANS EXCEPT CHANGES IN THE ORIGINAL THEORETICAL QUANTITIES FOR ACTUAL QUANTITIES. REFER TO PROJECT LEDGER AND/OR COMPUTATION BOOK.

Samuel M. ... 6/3/14
RESIDENT ENGINEER DATE

DEPARTMENT OF TRANSPORTATION
STATE OF HAWAII
APPROVED: *Paul F. ...* 5/16/03
DIR. OF TRANSPORTATION DATE