
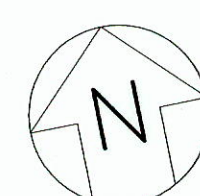


| INDEX TO DRAWINGS |                                       |
|-------------------|---------------------------------------|
| SHEET NO.         | DESCRIPTION                           |
| 1                 | TITLE SHEET                           |
| 2                 | STATE STANDARD PLAN SUMMARY           |
| 3                 | CONSTRUCTION NOTES & ABBREVIATIONS    |
| 4-8               | CONSTRUCTION NOTES                    |
| 9-10              | SITE PLANS                            |
| 11                | STRUCTURAL GENERAL NOTES              |
| 12                | KAAMILO - PLANS AND ELEVATION         |
| 13-16             | KAAMILO - DETAILS                     |
| 17                | LILIHA - PLANS AND ELEVATION          |
| 18-20             | LILIHA - DETAILS                      |
| 21                | ACCESS PLATFORM DETAILS               |
| 22-23             | ELECTRICAL PLANS                      |
| 24-25             | ONELINE DIAGRAMS                      |
| 26-27             | FREEWAY CLOSURE AND DETOUR ROUTE PLAN |
| 28-42             | TRAFFIC CONTROL PLANS                 |



STATE OF HAWAII  
DEPARTMENT OF TRANSPORTATION  
HIGHWAYS DIVISION  
HONOLULU, HAWAII  
**"AS-BUILT"**  
PLANS FOR  
FREEWAY MANAGEMENT SYSTEM, PHASE 1B  
TRAVELER INFORMATION SYSTEM, UNIT 4B:  
DYMANIC MESSAGE SIGN INSTALLATION  
FEDERAL-AID PROJECT NO. IM-0300(117)  
DISTRICTS OF HONOLULU AND EWA  
ISLAND OF OAHU

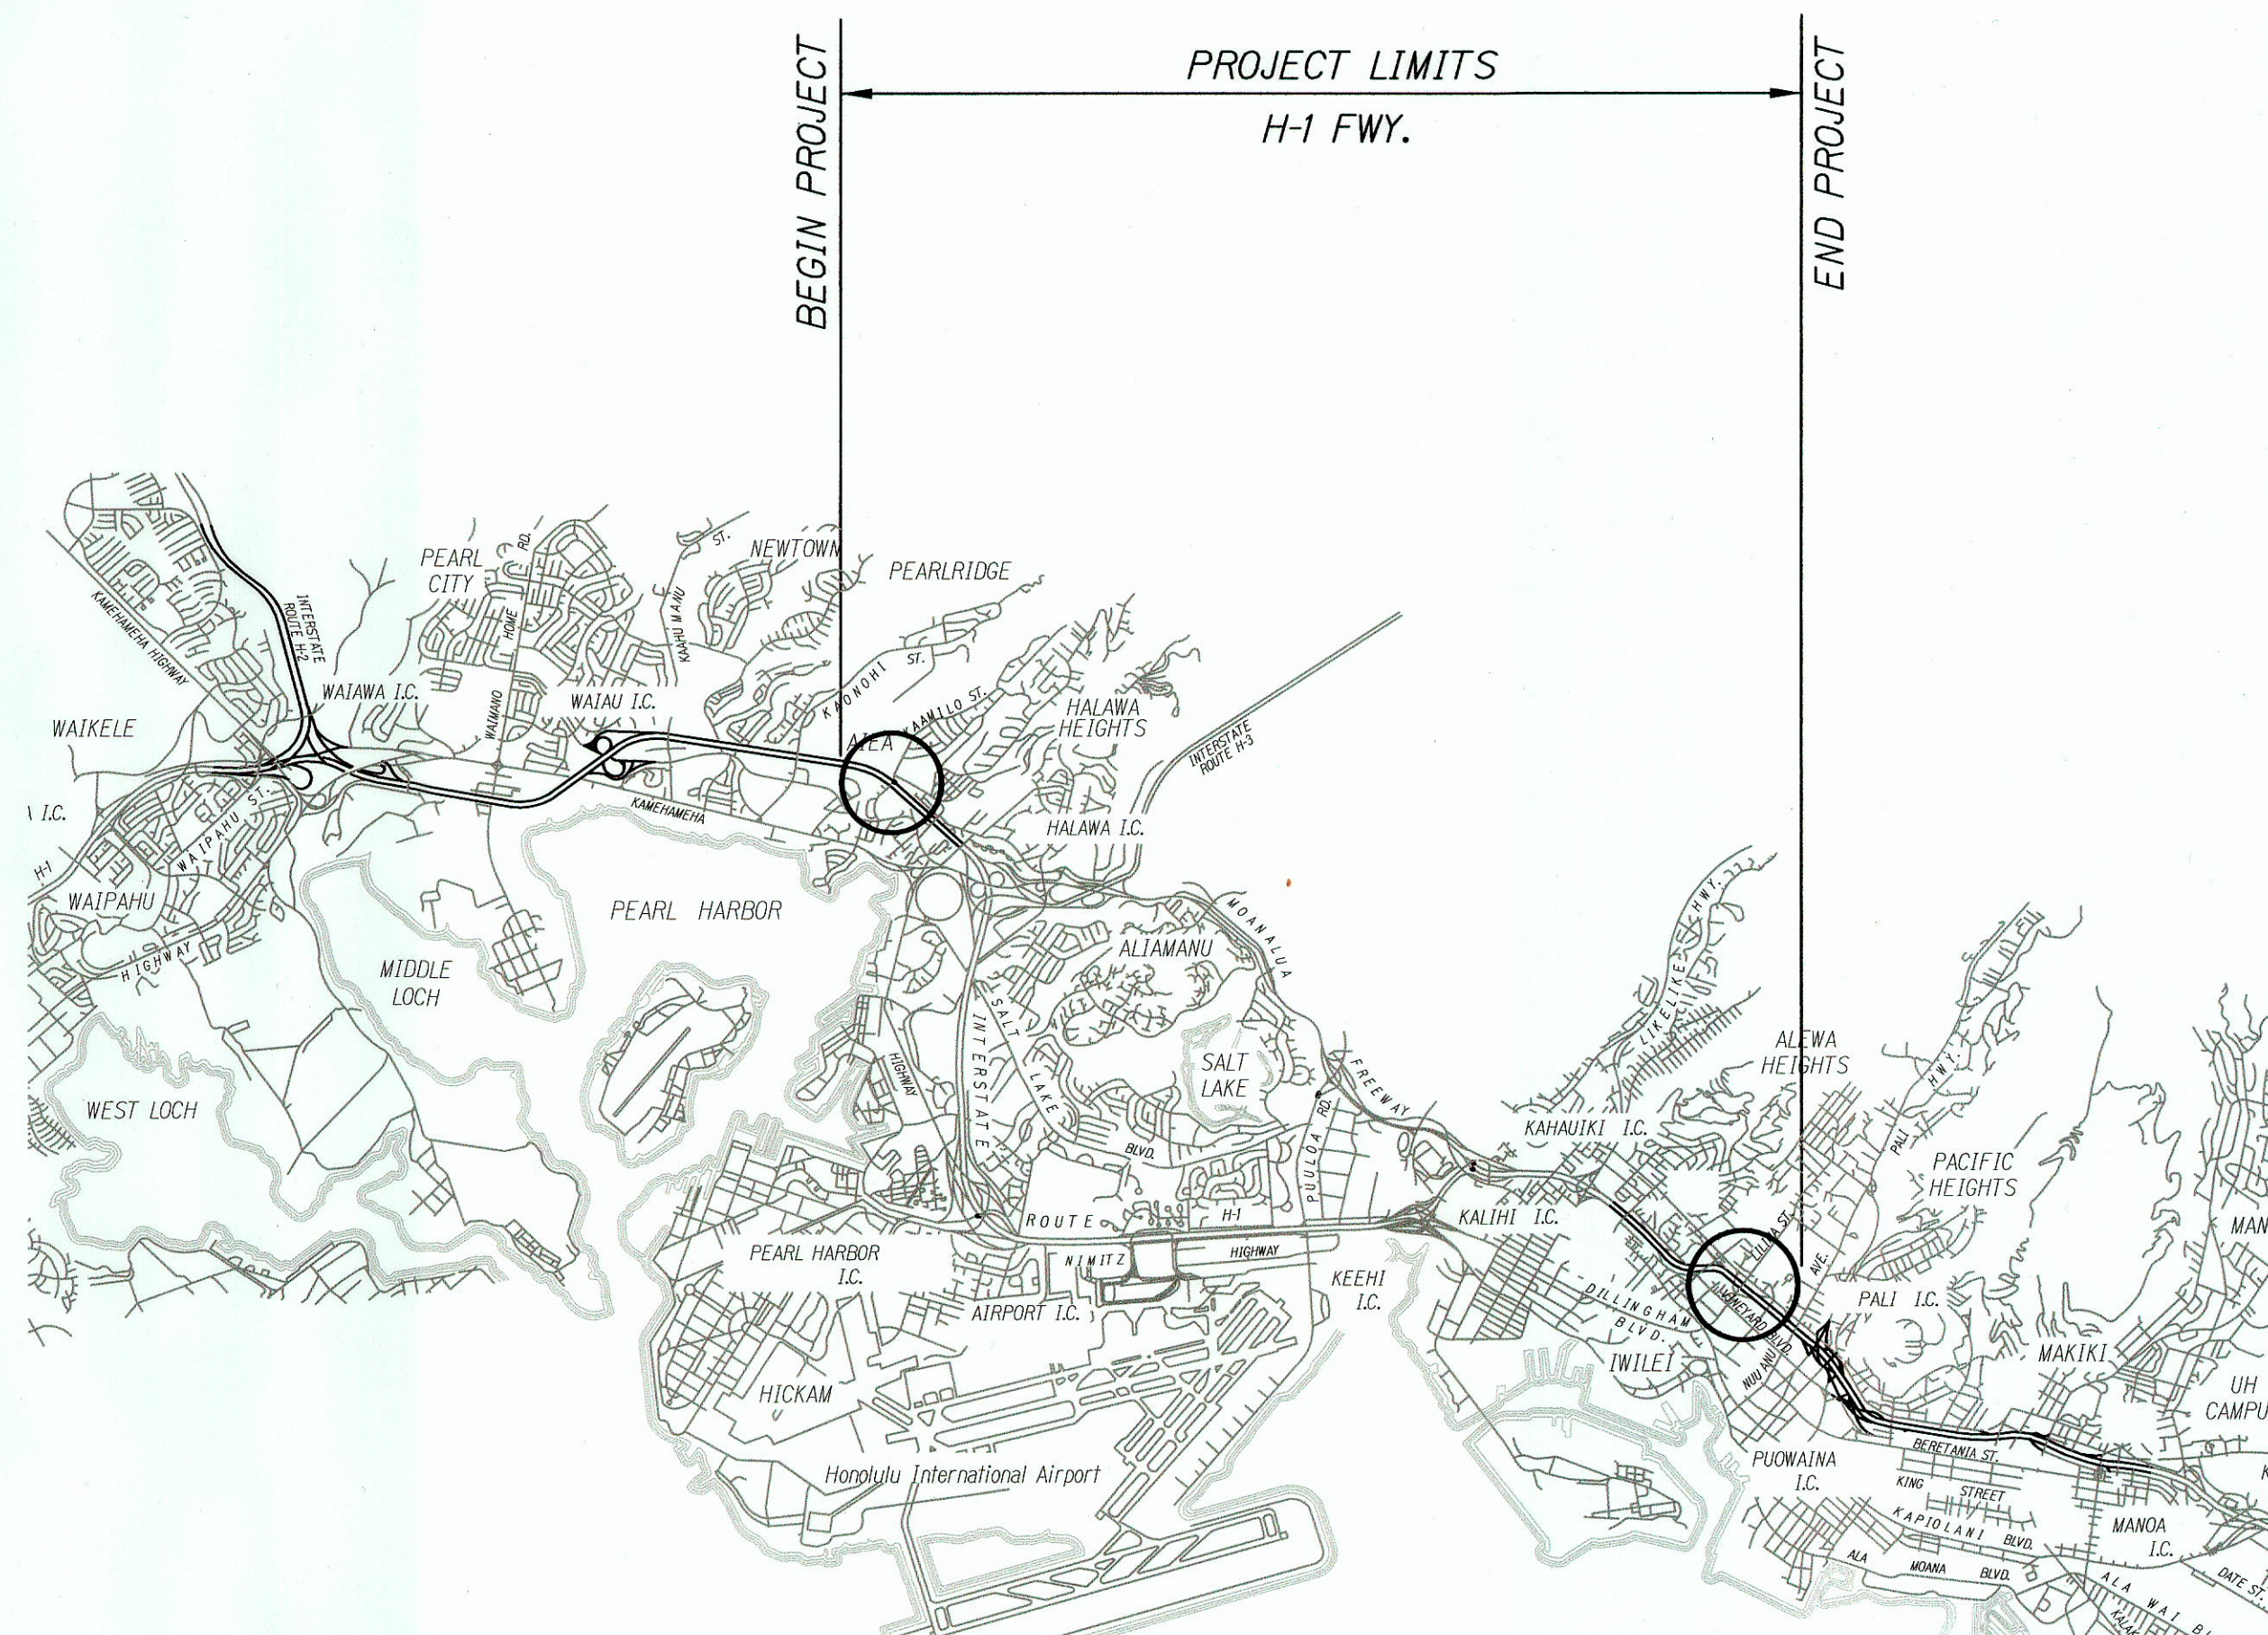

LAYOUT PLAN  
NOT TO SCALE

○ PROJECT SITES

| FED. ROAD DIST. NO. | STATE | FEDERAL AID PROJ. NO. | FISCAL YEAR | SHEET NO. | TOTAL SHEETS |
|---------------------|-------|-----------------------|-------------|-----------|--------------|
| HAWAII              | HAW.  | IM-0300(117)          | 2009        | 1         | 42           |

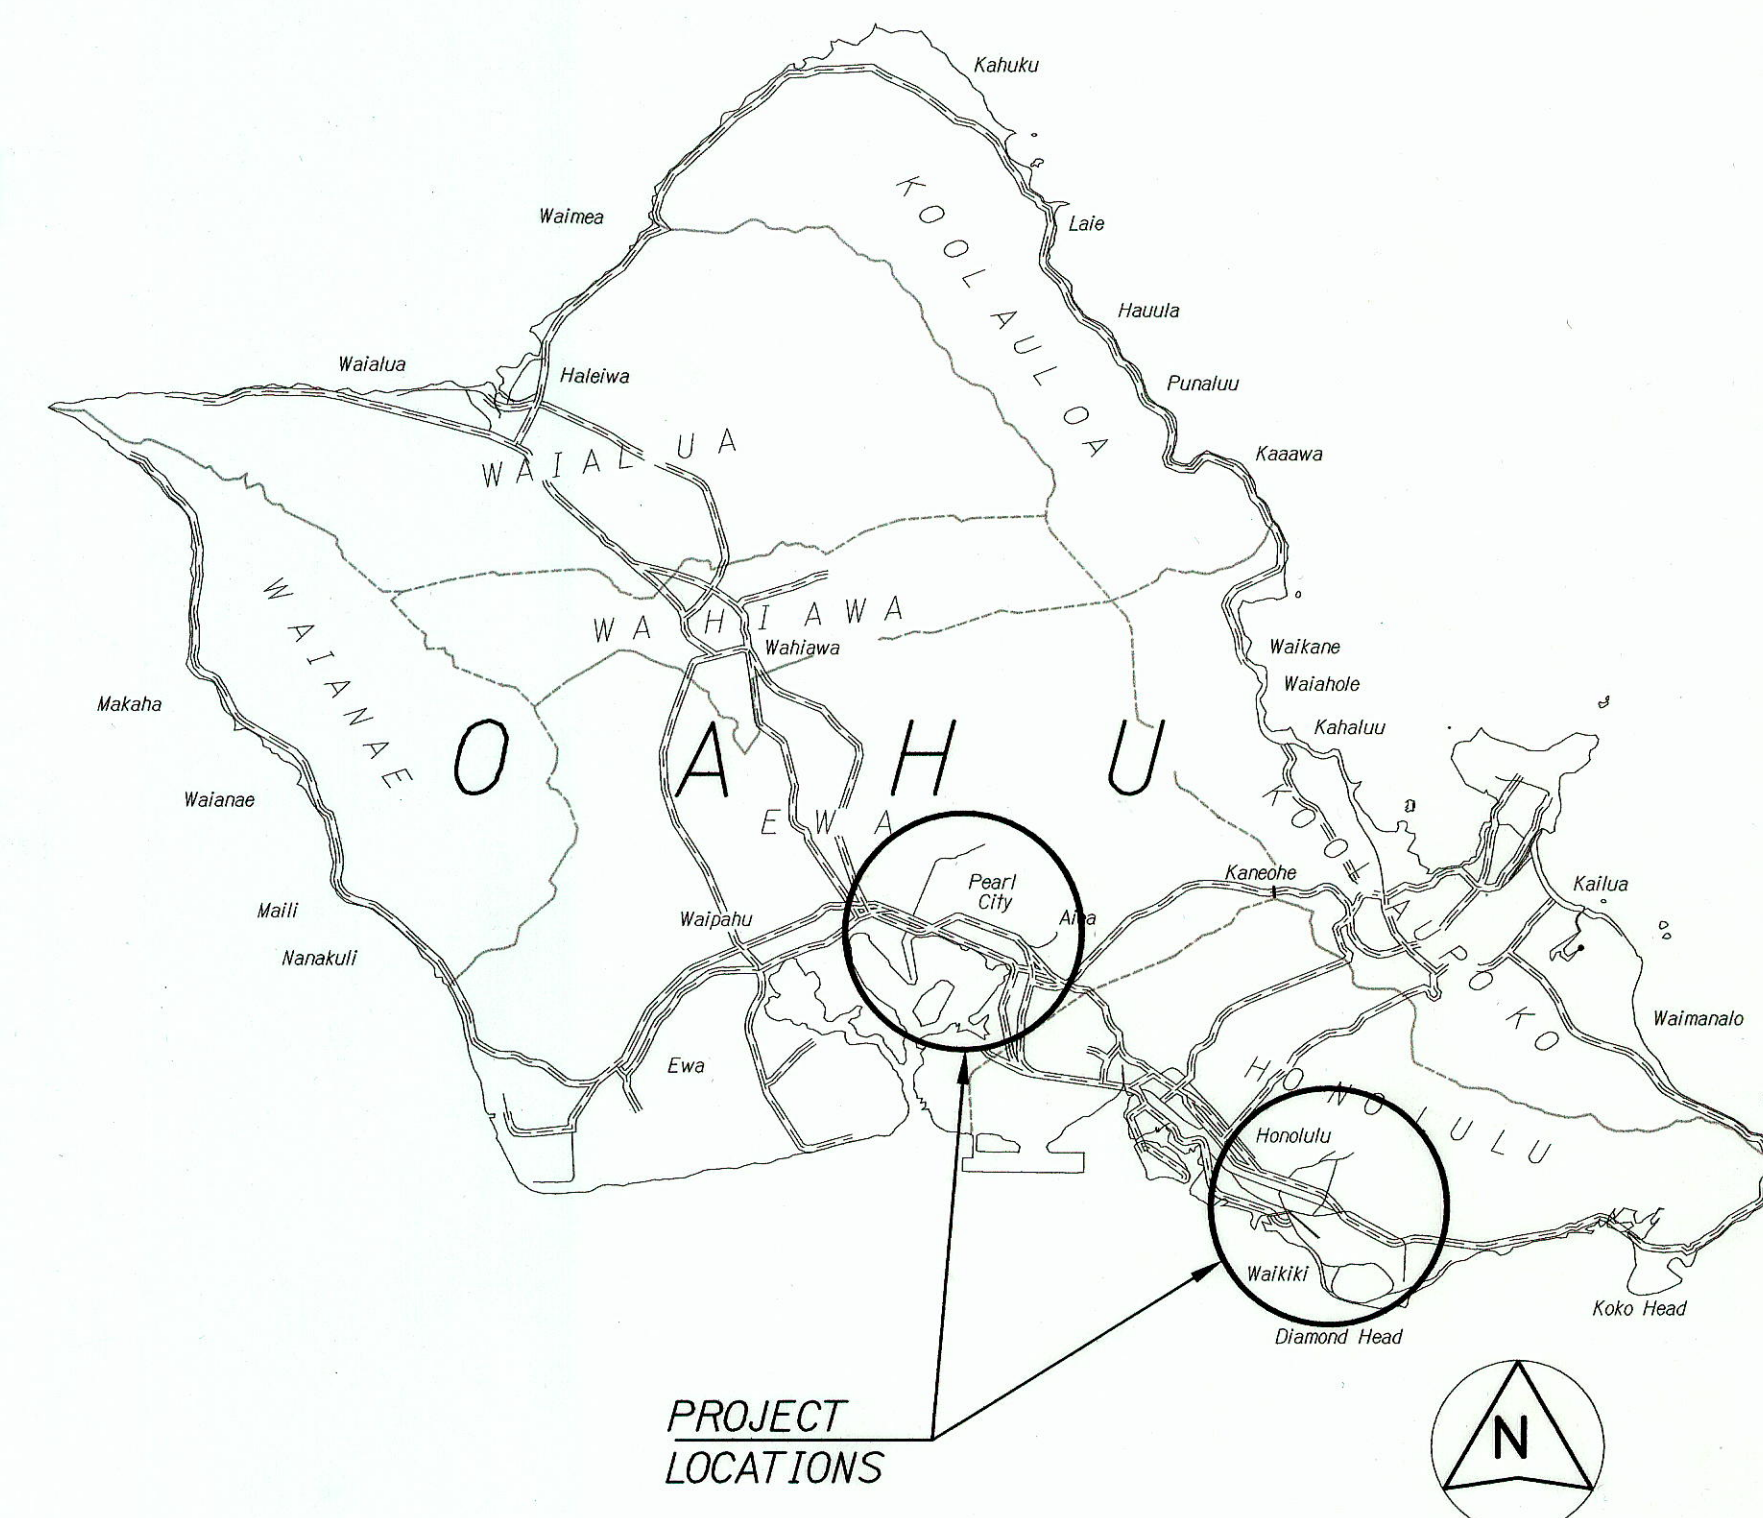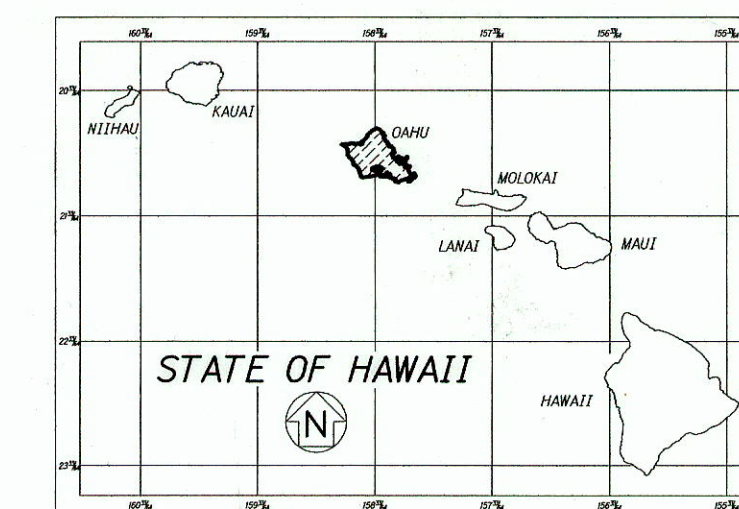

— FEDERAL AID PROJECTS PREVIOUSLY CONSTRUCTED OR UNDER CONSTRUCTION

H-1  
MILE POST 12.4 TO MILE POST 20.8

CHANGES MADE DURING CONSTRUCTION HAVE BEEN INCORPORATED ON THESE PLANS EXCEPT CHANGES IN THE ORIGINAL THEORETICAL QUANTITIES. FOR ACTUAL QUANTITIES, REFER TO PROJECT LEDGER AND/OR COMPUTATION BOOK.

Kevin Okazawa 6-22-18  
RESIDENT ENGINEER DATE

|                                                 |             |
|-------------------------------------------------|-------------|
| DEPARTMENT OF TRANSPORTATION<br>STATE OF HAWAII |             |
| APPROVED:                                       | DEC 22 2009 |
| <u>John M. Fanni</u><br>DIR. OF TRANSPORTATION  | DATE        |

ATA DESIGNED BY  
HWY-TO P. S. & E. BY  
692-7674 PHONE  
AUG 15, 2009 DATE