

INDEX TO DRAWINGS		COMPOSITE SHT. NO.
SHT.NO	DESCRIPTION	
1	Title Sheet	172
2	Layout Plan	173
3	Boring Plan	174
4-8	Typical Sections	① 175-179
9	Plan and Profile - General Notes	180
10-12	H-2 Outbound And H-2 Inbound	② 181-183
13-14	Ramp H2-0	184-185
15-17	Ramp H2-1	186-188
18	Ramp "N"	189
19	Ramp "M"	190
20-26	Superelevation Diagrams	191-197
27-28	Intersection Details	198-199
29-34	Drainage Details	③ 200-205
35	Sign Conversion Scheme And Interchange Opening Plan	206
36-42	Pavement Markers, Signing, And Striping Details	207-213
43-77	Miscellaneous And Standard Details	④ 214-248
78-85	Highway Lighting Plans And Details	⑤ 249-256
86-104	Cross Sections	⑥ 257-275

Supplementary sheets to this project are Sht. Nos.:

- ① C.O. 179 S-1
- ② C.O. 182 R S-1
- ③ C.O. 200 S-1
- ④ ADD. 240 S-1, C.O. 246 S-1
- ⑤ C.O. 254 S-1
- ⑥ 275 S-1, 275 S-2, 275 S-3

STATE OF HAWAII

DEPARTMENT OF TRANSPORTATION

HIGHWAYS DIVISION

HONOLULU, HAWAII

"AS BUILT"

PLANS FOR

CONSTRUCTION OF A PORTION OF

INTERSTATE ROUTE H-1

WAIAWA INTERCHANGE

(PAVING OF H-2 CONNECTION)

FEDERAL AID INTERSTATE PROJECT No. I - HI - I(46):8


DISTRICT OF EWA
ISLAND OF OAHU

SCALES:

PLAN & PROFILE	HOR.	1" = 50'
	VER.	1" = 10'
DETAIL ROADWAY PLAN		1" = 20'
CROSS SECTION	HOR. & VER.	1" = 20'
	HOR. & VER.	1" = 10'

DESIGN CLASSIFICATION

CURRENT ADT (1973)	0
INTERIM ADT (1977)	27,800
DESIGN ADT (1993)	47,200
DHV	10 %
D	60/40
T24	1,200
V	70 m.p.h.
CONTROL OF ACCESS	FULL

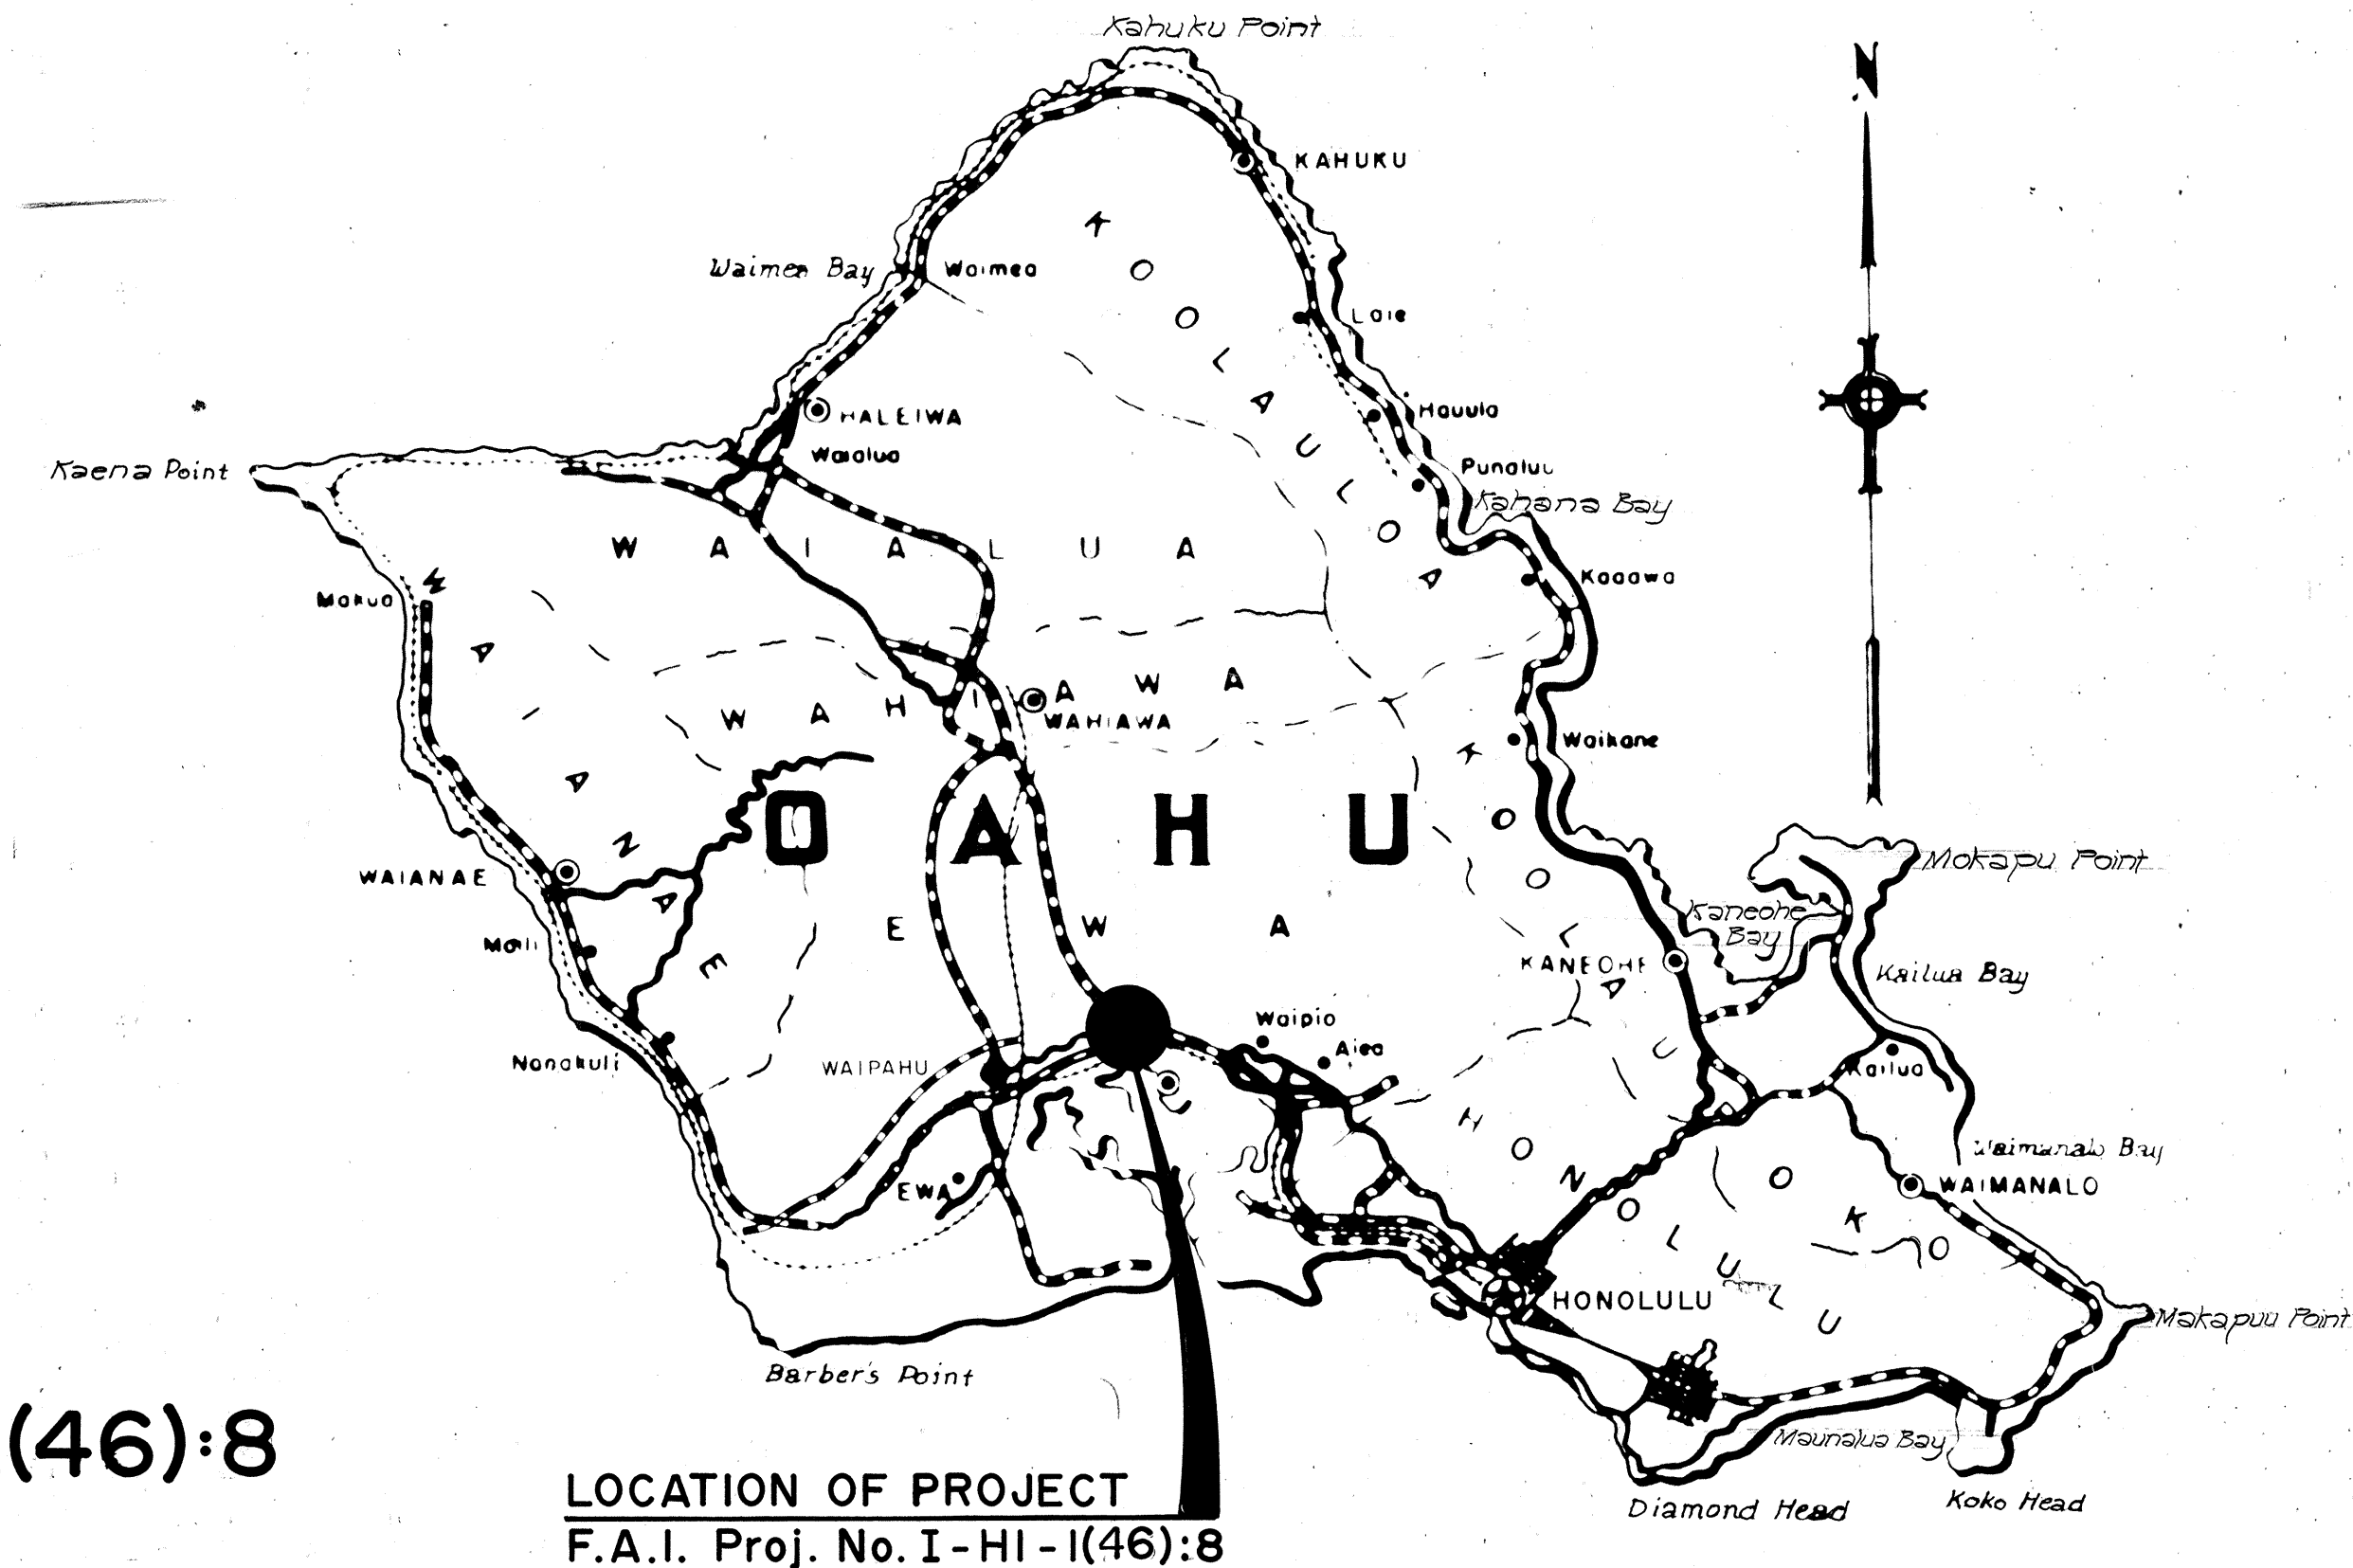

Federal Aid Projects Previously Constructed Or Under Construction

NOTE:

ALL CHANGES MADE DURING CONSTRUCTION HAVE BEEN INCORPORATED ON THESE PLANS IN RED EXCEPT CHANGES IN THE ORIGINAL THEORETICAL QUANTITIES. FOR ACTUAL QUANTITIES, REFER TO PROJECT LEDGER AND/OR COMPUTATION BOOK.

Halley H. Markew
PROJECT ENGINEER

29 Nov 76
DATE

APPROVED: Date: 8 June 79

Louis H. H. H.
DIRECTOR OF TRANSPORTATION

DEPARTMENT OF TRANSPORTATION
FEDERAL HIGHWAY ADMINISTRATION

APPROVED

W. B.
DIVISION ENGINEER

5/7/73
DATE

DATE	APR. 1973
DESIGNED BY	MIKE MIURA
CHECKED BY	P. S. & E. BY
NOTED BY	DESIGN UNIT
DATE	APR. 1973

SUNN, LOW, TOM & HARA, INC.
DESIGNED BY

548-7490
PHONE

APR. 1973
DATE