

INDEX TO DRAWINGS	
SHEET NO.	DESCRIPTION
1	TITLE SHEET
2-9	LANDSCAPING PLANTING PLANS & DETAILS
*10-31	SPRINKLER SYSTEM SPRINKLER PLANS & DETAILS
*C025S-1	

TOTAL SHEET COUNT AFTER "AS-BUILT"
POSTINGS: 32 SHEETS

STATE OF HAWAII
DEPARTMENT OF TRANSPORTATION
HIGHWAYS DIVISION
HONOLULU, HAWAII

**"AS-BUILT" PLANS FOR
INTERSTATE ROUTE H-2
WAHIAWA INTERCHANGE
AND
LEILEHUA INTERCHANGE
LANDSCAPING AND SPRINKLER SYSTEM
FED. AID INTERSTATE PROJ. NO. I-H2-1(17):6**

DISTRICTS OF WAHIAWA AND EWA
ISLAND OF OAHU


ALL CHANGES MADE DURING CONSTRUCTION HAVE BEEN INCORPORATED ON THESE PLANS IN RED EXCEPT CHANGES IN THE ORIGINAL THEORETICAL QUANTITIES. FOR ACTUAL QUANTITIES, REFER TO PROJECT LEDGER AND/OR COMPUTATION BOOK.

Garnet D. Okada
RESIDENT ENGINEER

Oct. 26, 1979
DATE

DESIGN DESIGNATION

CURRENT ADT (1976) 0
INTERIM ADT (1977) . . . 24,971
DESIGN ADT (1993) . . . 35,900
DHV 10 %
D 55/45
T₂₄ 1,200
V 50 mph
CONTROL OF ACCESS . . . FULL

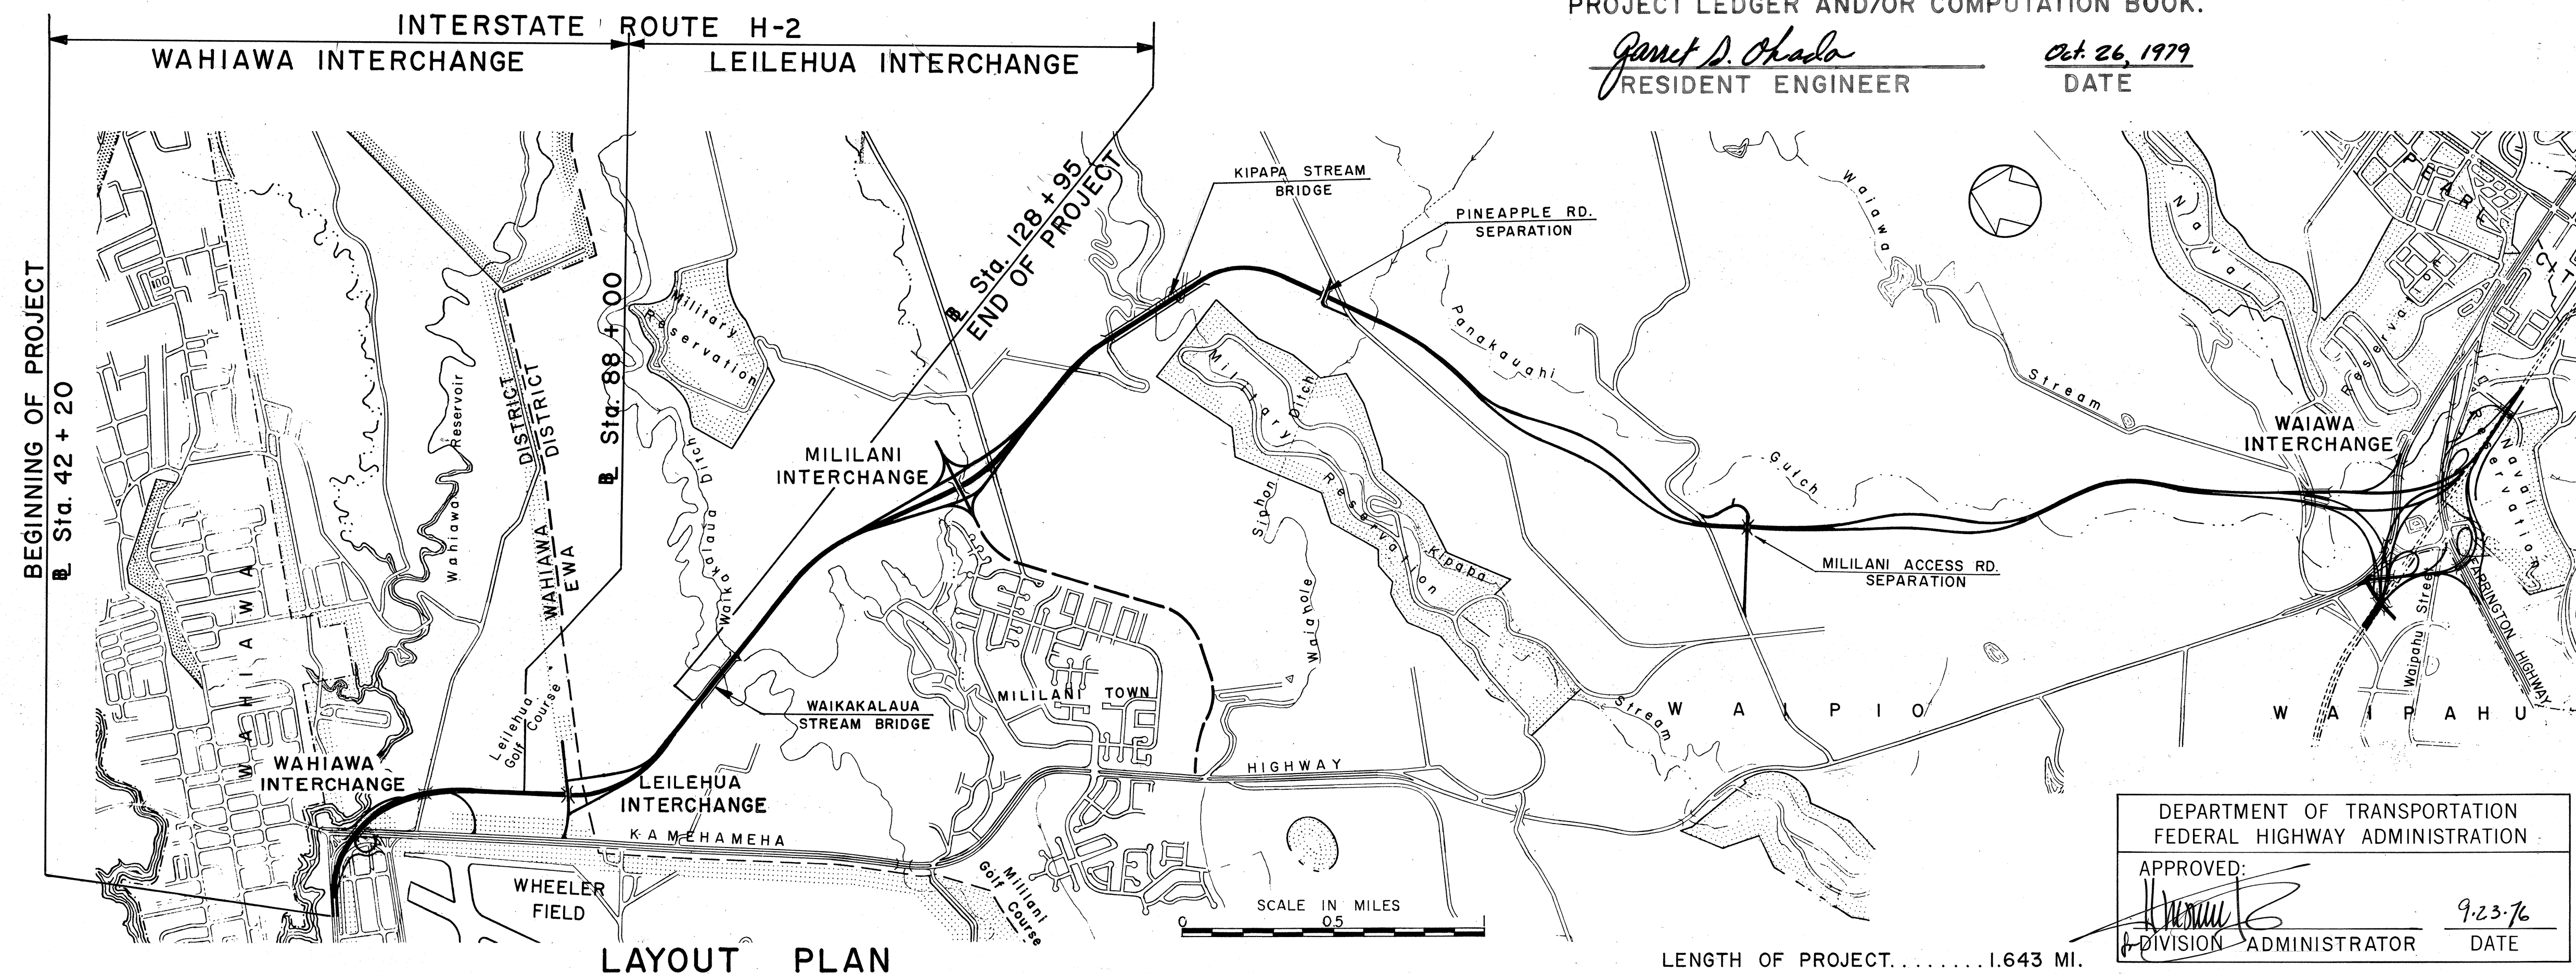

LAYOUT PLAN


LENGTH OF PROJECT 1.643 MI.

DEPARTMENT OF TRANSPORTATION
FEDERAL HIGHWAY ADMINISTRATION
APPROVED: *[Signature]* 9-23-76
DIVISION ADMINISTRATOR DATE

DEPARTMENT OF TRANSPORTATION
STATE OF HAWAII
APPROVED: *R. Higashimura* 9-29-76
for DIR. OF TRANSPORTATION DATE

M. Miura 548-7400 *Sept. 1976*
P. S. & E. BY PHONE DATE

FED. ROAD DIST. NO.	STATE	FED. AID PROJ. NO.	FISCAL YEAR	SHEET NO.	TOTAL SHEETS
HAWAII	HAW.	I-H2-1(17):6	1976	1	31

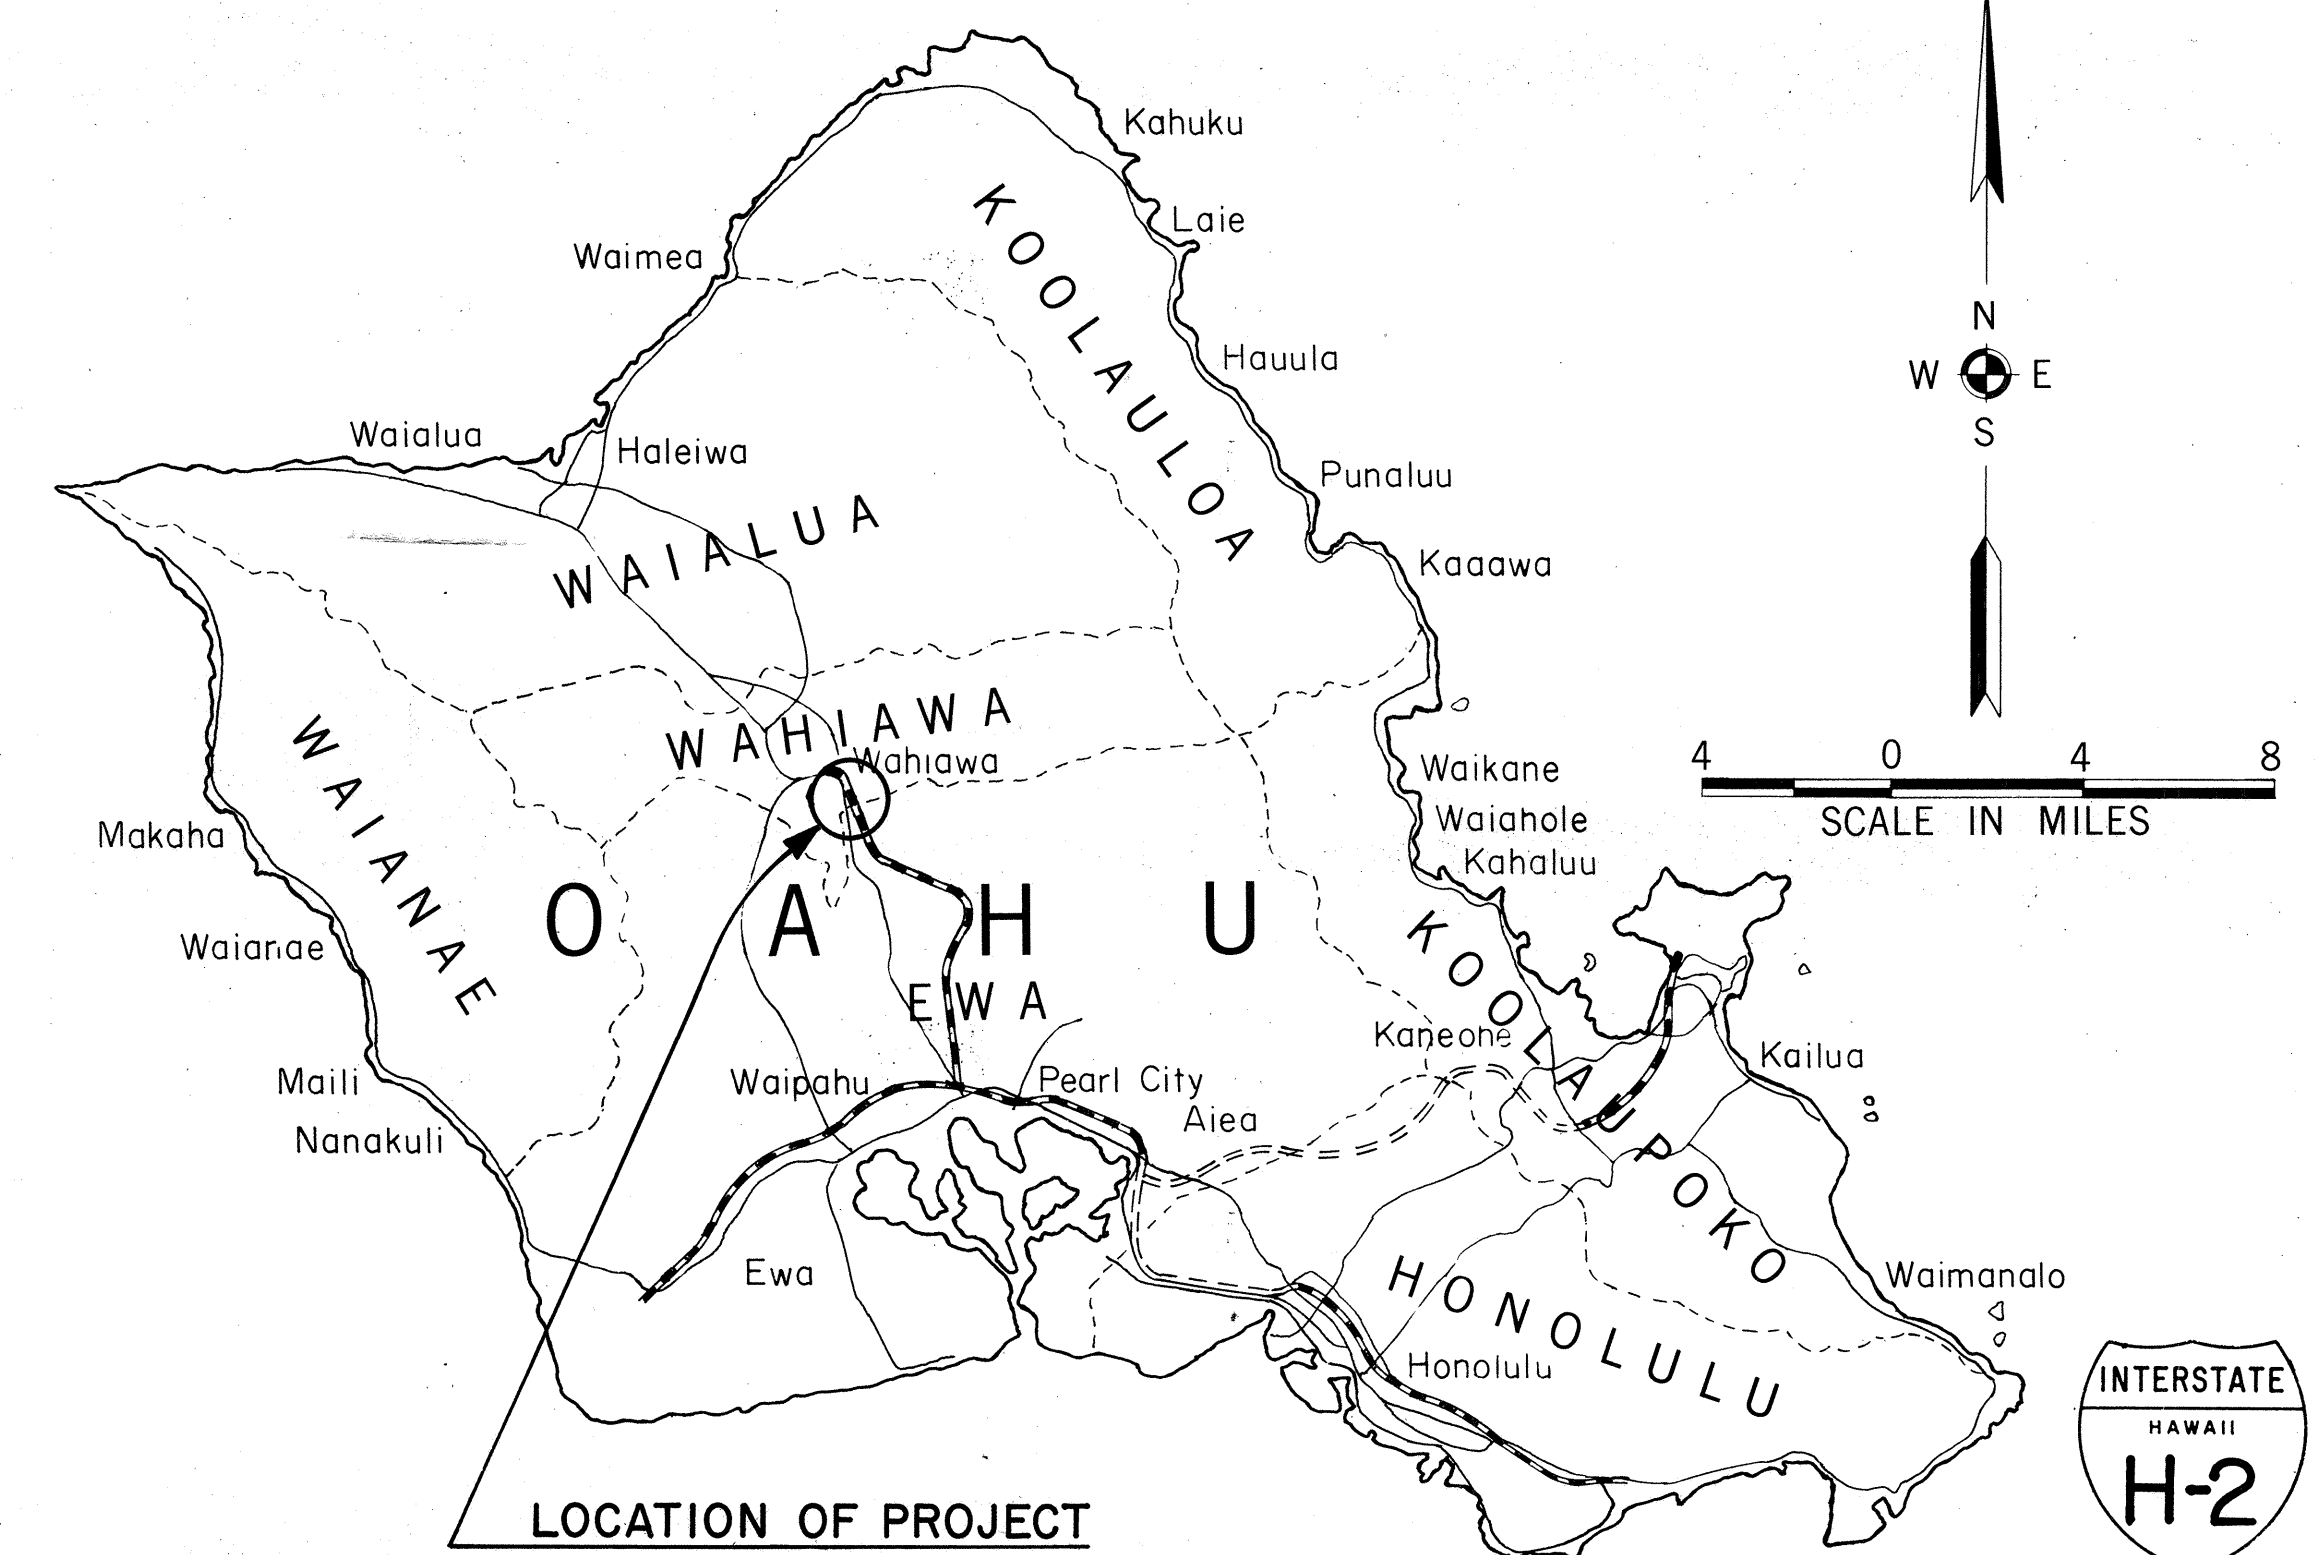

LOCATION OF PROJECT

— Federal Aid Interstate Projects Previously Constructed or Under Construction