

INDEX TO DRAWINGS	
SHEET NO.	DESCRIPTION
1	TITLE SHEET
2	STANDARD PLANS SUMMARY
3	NOTES & LEGEND
4	TYPICAL SECTIONS
5	HM-2 PAVEMENT WIDENING PLAN
* 6	TRAFFIC SIGNAL SYSTEM
7	2" & 2 1/2" A.C. OVERLAY, STRIPING, MARKING & SIGNING PLAN
8	STRIPING, MARKING & SIGNING PLAN
9	LOOP DETECTOR DETAILS
10	ELECTRICAL DETAILS
11	CROSS SECTIONS
12	TRAFFIC CONTROL PLAN

*C.O.6A IS A SUPPLEMENT SHEET
THE CONTRACT PLANS.
NEW TOTAL = 13

STATE OF HAWAII

DEPARTMENT OF TRANSPORTATION

HIGHWAYS DIVISION

HONOLULU, HAWAII

"AS-BUILT"

PLANS FOR

H-2 MILILANI INTERCHANGE


HM-2 OFF-RAMP WIDENING AND

TRAFFIC SIGNALS AT MEHEULA PARKWAY

F.A. PROJECT NO. IR-H2-1(25)

DISTRICT OF EWA

ISLAND OF OAHU

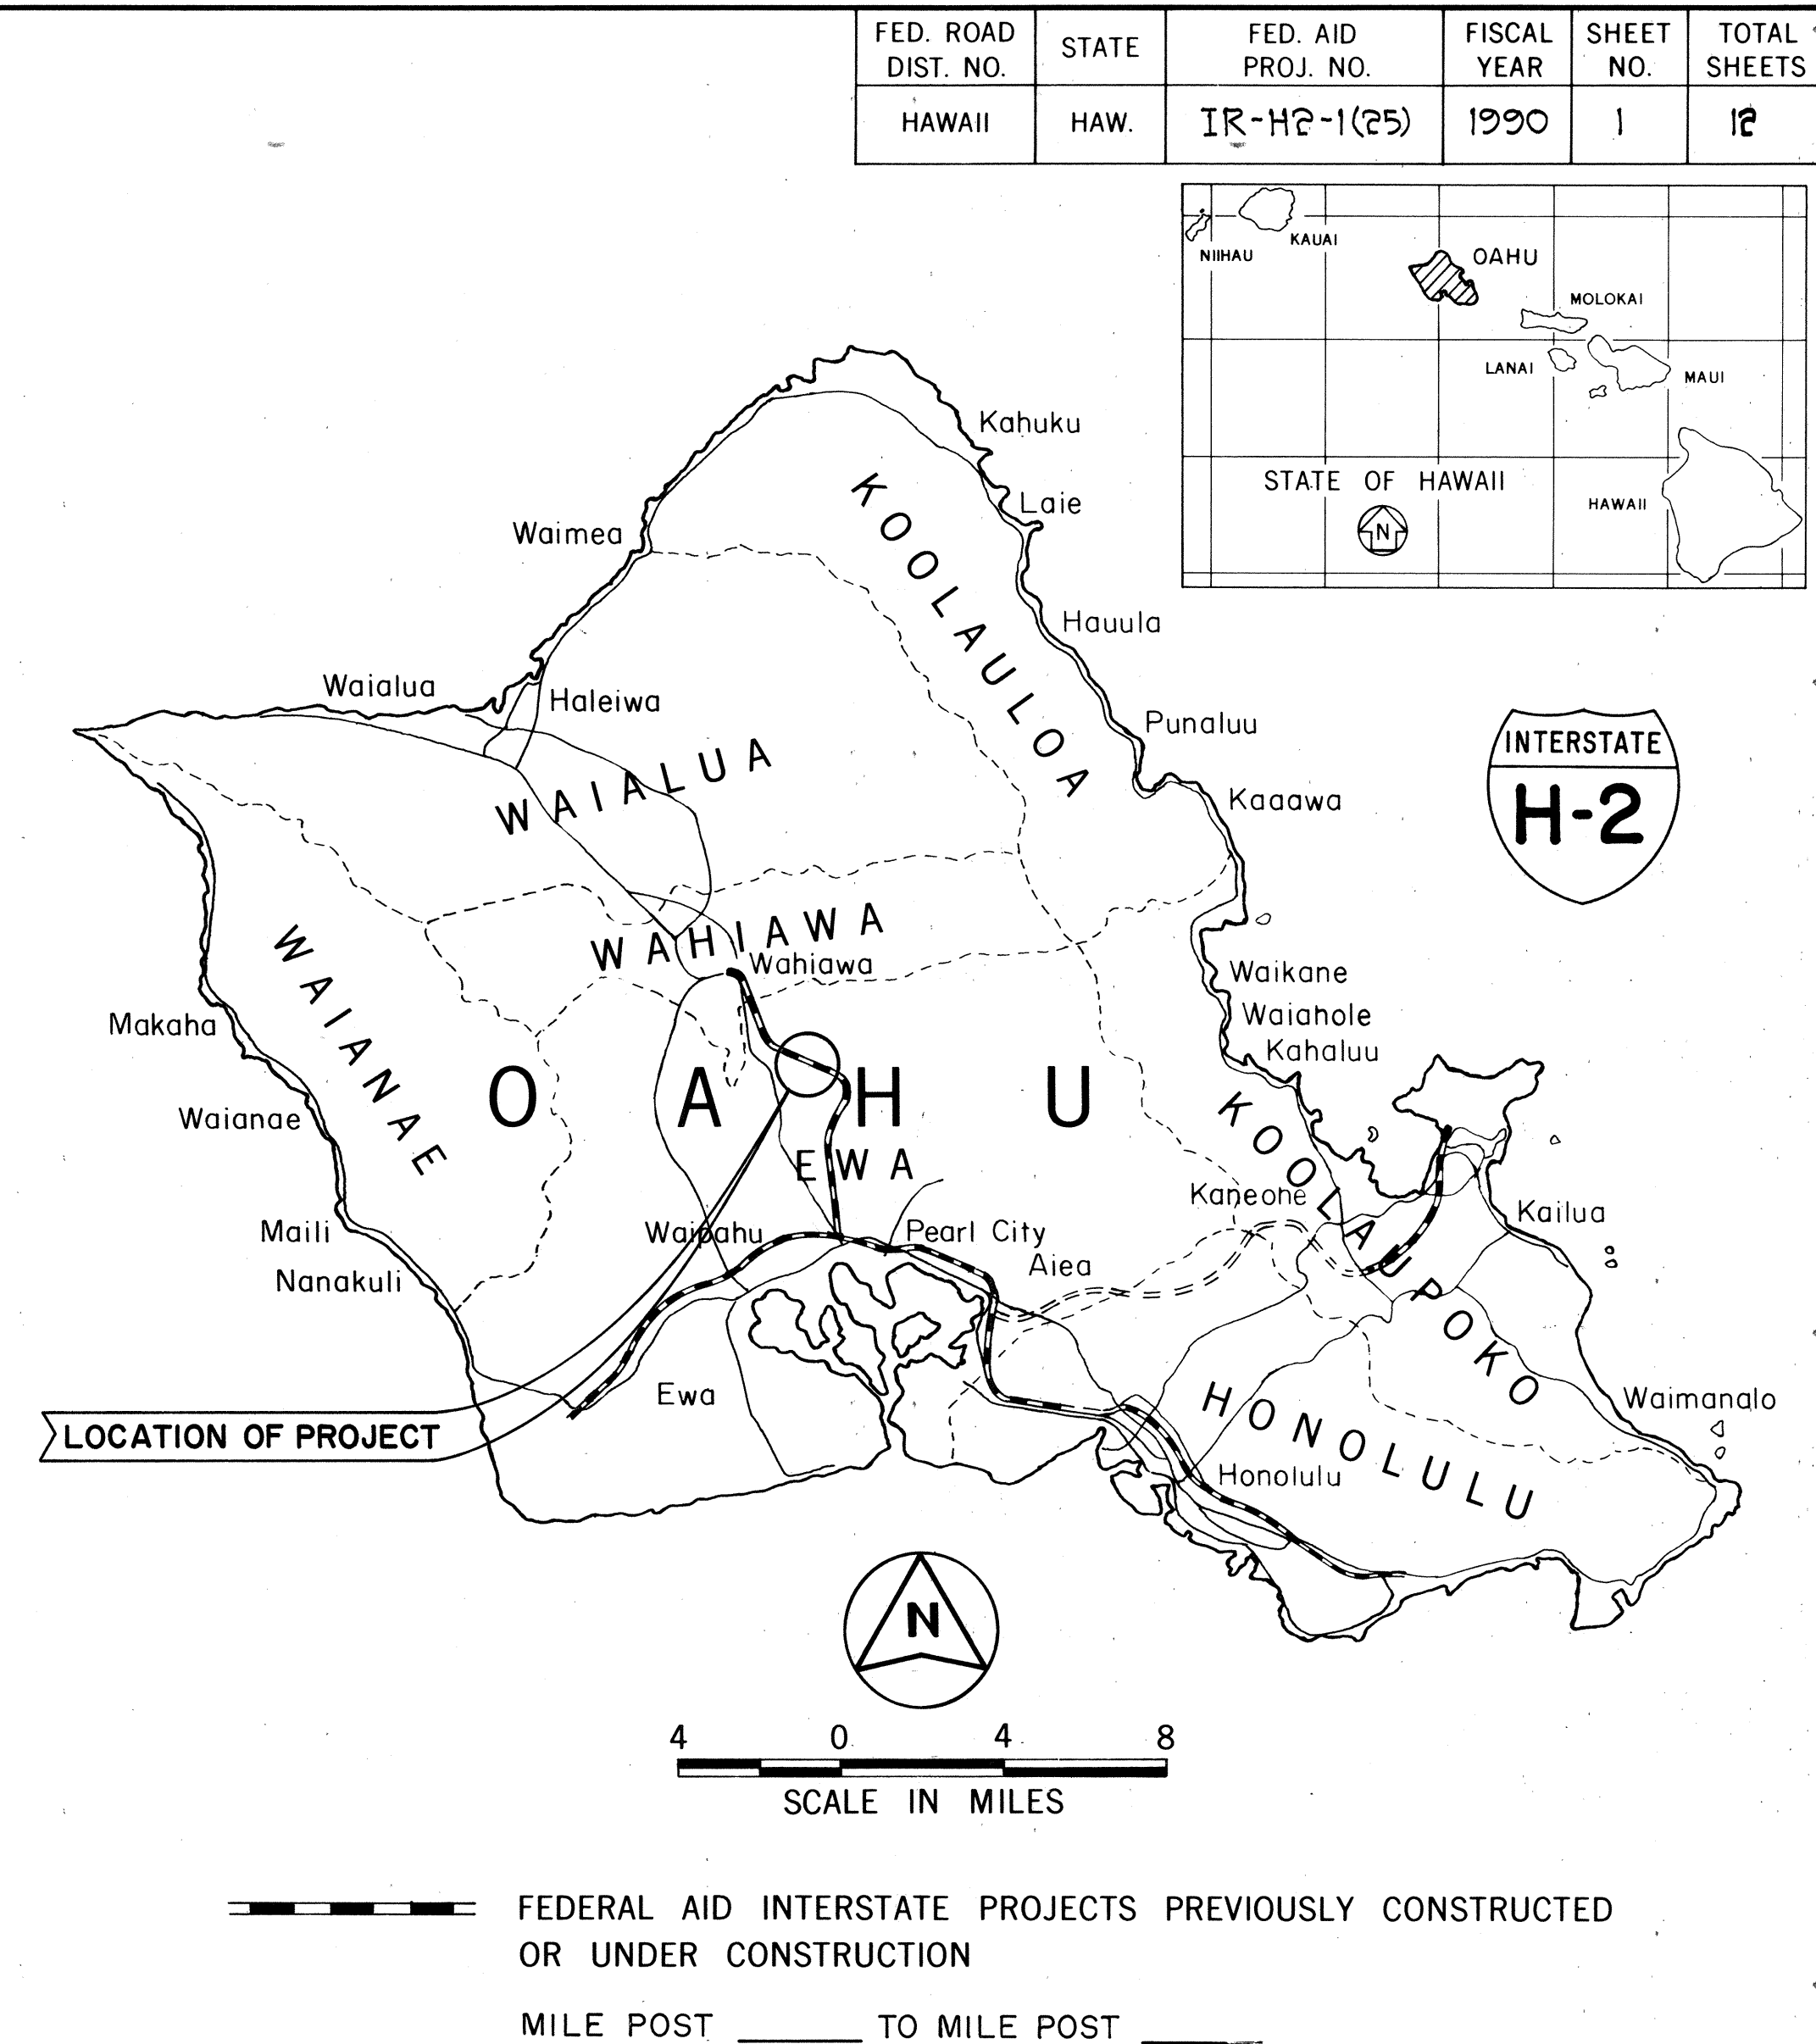

DESIGN CLASSIFICATION


DESIGN ADT (1992)	81,363
DHV	8,544
D	60/40
T	2%
V	35 MPH

CHANGES MADE DURING CONSTRUCTION HAVE BEEN INCORPORATED ON THESE PLANS EXCEPT CHANGES IN THE ORIGINAL THEORETICAL QUANTITIES. FOR ACTUAL QUANTITIES, REFER TO PROJECT LEDGER AND/OR COMPUTATION BOOK.

Michael Dineen
RESIDENT ENGINEER
7/13/93
DATE

DEPARTMENT OF TRANSPORTATION
FEDERAL HIGHWAY ADMINISTRATION
APPROVED:
William J. ...
DIVISION ADMINISTRATOR
10/13/99
DATE

DEPARTMENT OF TRANSPORTATION
STATE OF HAWAII
APPROVED:
Edward ...
DIR. OF TRANSPORTATION
8/23/99
DATE

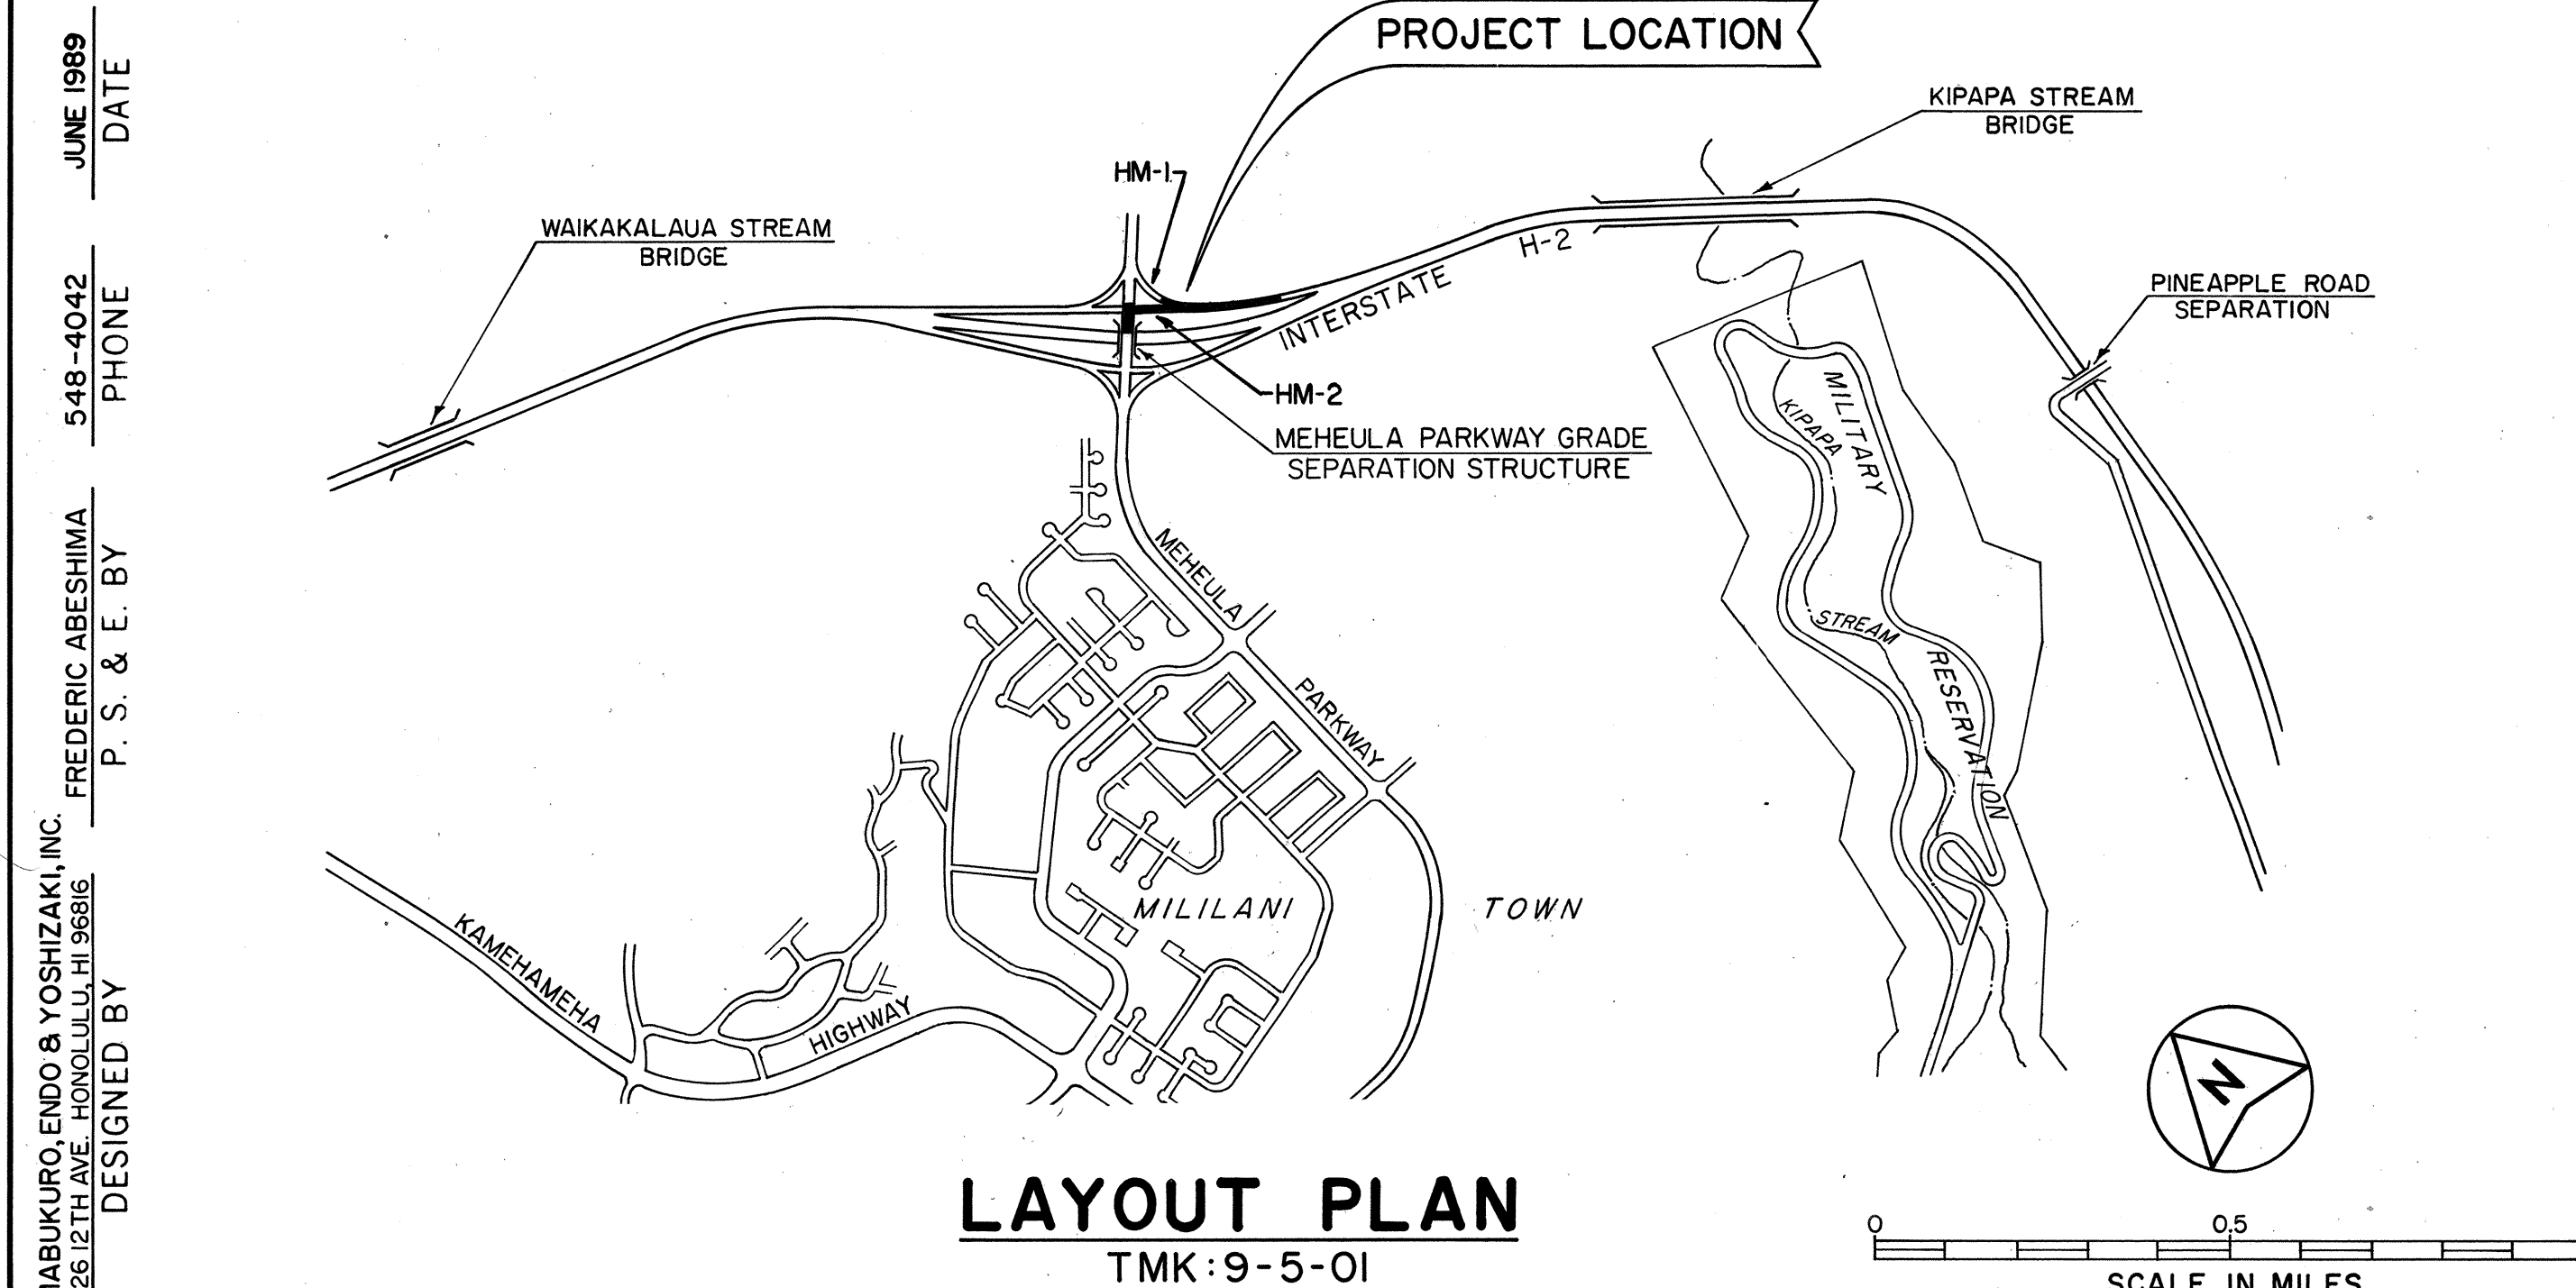

SHIMABUKURO, ENDO & YOSHIZAKI, INC.
1126 12TH AVE., HONOLULU, HI 96813
DESIGNED BY
P. S. & E. BY
FREDERIC ABESHIMA
548-4042
PHONE
JUNE 1989
DATE

C-5-4