

INDEX TO DRAWINGS	
SHEET NO.	DESCRIPTION
1	TITLE SHEET
2	STANDARD PLANS SUMMARY
3 - 6	CONSTRUCTION NOTES
7 - 8	WHEELCHAIR RAMPS STANDARD PLANS
9 - 17	ALIGNMENT & ROADWAY CONSTRUCTION
18	INTERSECTION DETAILS
19 - 20	PROFILES
21 - 22	SUPER ELEVATION DIAGRAMS
23 - 24	SPOT ELEVATION PLAN
25 - 33	TYPICAL SECTIONS
34 - 46	MISCELLANEOUS DETAILS
47 - 48	PHASING PLANS
49 - 68	TRAFFIC CONTROL PLANS
69 - 74	SIGNING & PAVEMENT MARKINGS
75 - 76	GRADING & EROSION CONTROL PLANS
77 - 87	DRAINAGE PLANS
88 - 89	BORING LOGS
90 - 99	RETAINING WALLS
100 - 110	ELECTRICAL PLANS
111 - 118	TRAFFIC SIGNAL SYSTEM
119 - 129	CROSS SECTIONS

MAR. 1997
DATE

587-2250
PHONE

ROSS HIRONAKA
P.S. & E. BY

FUJITA & ASSOC. INC.
DESIGNED BY

Plan Sheet Nos. C.O. 75-1, C.O. 75-2,
And C.O. 75-3 Are Supplementary Sheets
to the Original Contract Plans.
TOTAL SHEET COUNT AFTER "AS-BUILT"
Posting to 132 Sheets.

STATE OF HAWAII
DEPARTMENT OF TRANSPORTATION
HIGHWAYS DIVISION
HONOLULU, HAWAII


"AS BUILT"
PLANS FOR

INTERSTATE ROUTE H-2
MILILANI INTERCHANGE
SOUTHBOUND ON-AND OFF-RAMPS

FEDERAL AID INTERSTATE PROJECT NO. IM-H2-1(29)

TMK: 9-5-44:142, 143

DISTRICT OF EWA
ISLAND OF OAHU

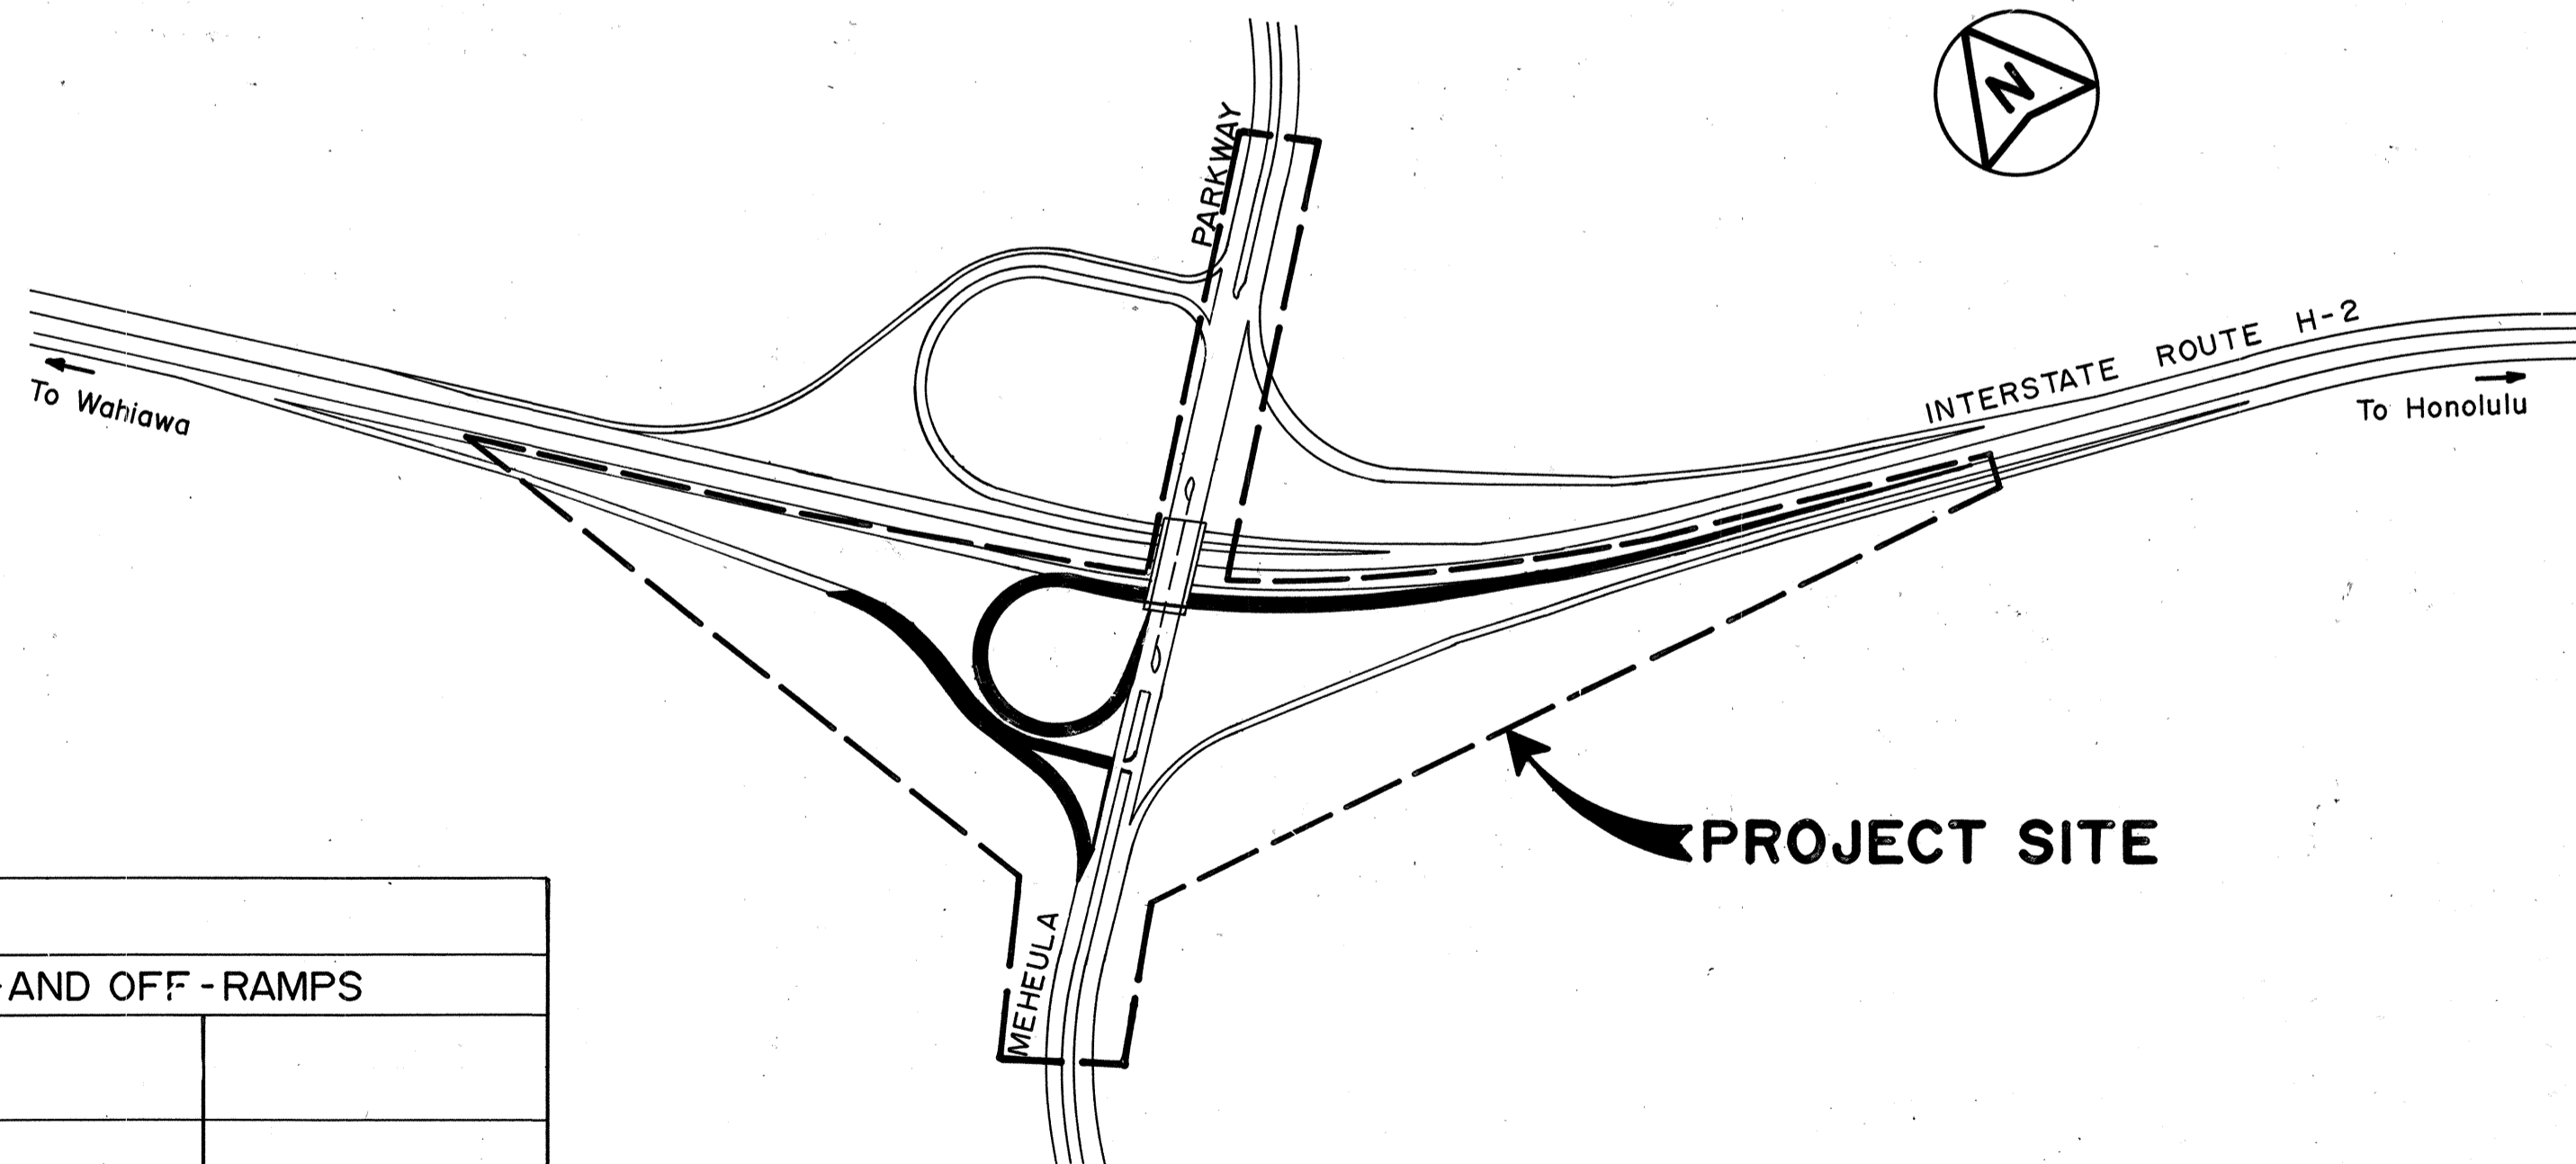


LOCATION MAP

SCALE: 1" = 400'

DESIGN DESIGNATION				
H-2 MILILANI INTERCHANGE SOUTHBOUND ON-AND OFF-RAMPS				
	RAMP R-1/R-2 (IN ENTIRETY)	RAMP R-3 (IN ENTIRETY)		
CURRENT ADT (1995)	3,900	3,664		
DESIGN ADT (2005)	9,900	15,300		
T 24	2.2%	2.2%		
V	25 M.P.H.	25 M.P.H.		
DHV	340 FOR R-1/ 320 FOR R-2	1,840		

FED. ROAD DIST. NO.	STATE	FED. AID PROJ. NO.	FISCAL YEAR	SHEET NO.	TOTAL SHEETS
HAWAII	HAW.	IM-H2-1(29)	1997	1	129

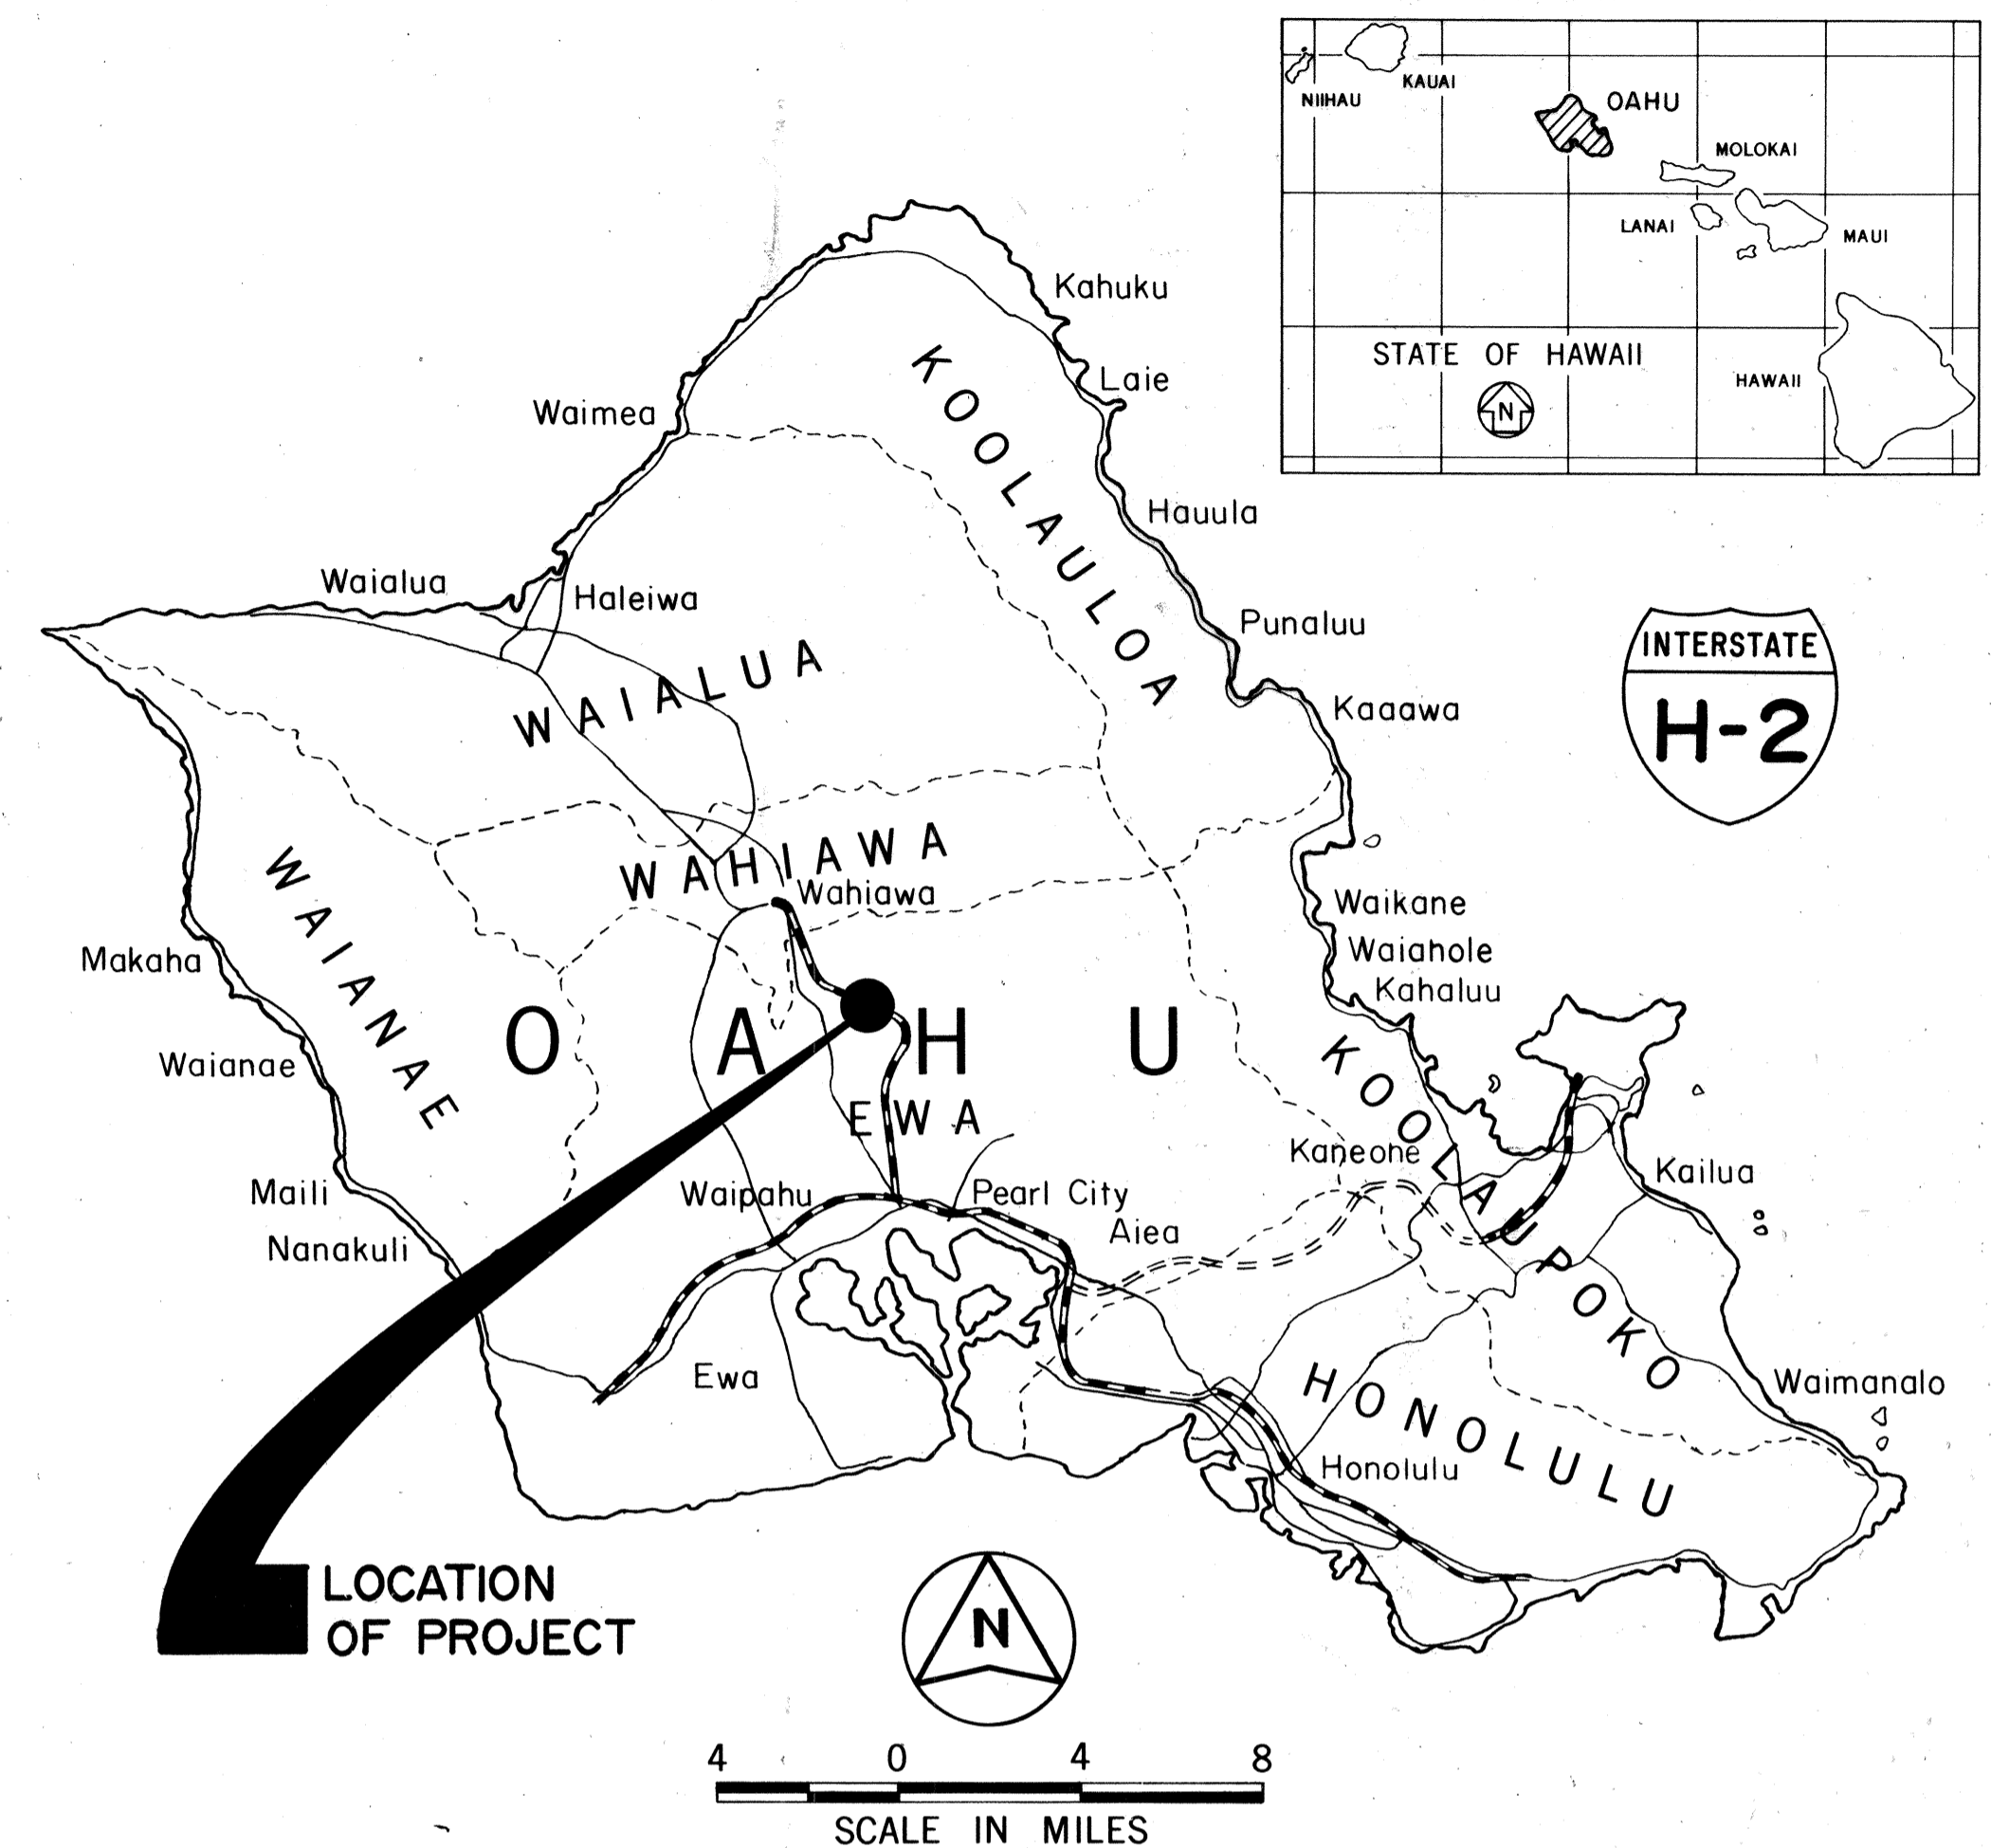

FEDERAL AID INTERSTATE PROJECTS PREVIOUSLY CONSTRUCTED
OR UNDER CONSTRUCTION
MILE POST 5.44 TO MILE POST 4.94

CHANGES MADE DURING CONSTRUCTION HAVE
BEEN INCORPORATED ON THESE PLANS EXCEPT
CHANGES IN THE ORIGINAL THEORETICAL
QUANTITIES. FOR ACTUAL QUANTITIES, REFER TO
PROJECT LEDGER AND/OR COMPUTATION BOOK.

RESIDENT ENGINEER

DATE

DEPARTMENT OF TRANSPORTATION
STATE OF HAWAII
APPROVED:
DIRECTOR

DEPARTMENT OF TRANSPORTATION
STATE OF HAWAII
APPROVED:
DATE