

INDEX TO DRAWINGS	
SHEET NO.	DESCRIPTION
1	TITLE SHEET
2	STANDARD PLANS SUMMARY
3	GENERAL NOTES AND LEGEND
4 - 5	WATER POLLUTION & EROSION CONTROL NOTES
6 - 17	TYPICAL SECTION AND DETAILS
18 - 22	P.C.C. PAVEMENT DETAILS
23 - 26	CURB RAMP DETAILS
27	MISCELLANEOUS DETAILS
28	DETECTABLE WARNING DETAILS
29 - 30	MILILANI INTERCHANGE CURBRAMPS
31 - 41	GUARDRAIL DETAILS
42	DEMOLITION PLANS
43 - 59	ROADWAY PLANS
60 - 63	DRAINAGE DETAILS
64	PLAN & PROFILE - 30" DRAIN LINE
65 - 71	MEHEULA PARKWAY SEPARATION
72	FREEWAY WORKZONE SIGNING, PLAN, NOTES AND DETAILS
73	PORTABLE CONCRETE BARRIER
74 - 75	TRAFFIC CONTROL & DETOUR CONTROL NOTES & LEGEND
76 - 112	CONSTRUCTION PHASING PLANS
113	PAVEMENT MARKING, LEGEND, DETAILS AND NOTES
114 - 127	PAVEMENT MARKING & SIGNING PLANS
128 - 129	DESTINATION & EXPRESSWAY SIGN PANEL LAYOUTS
130 - 134	LOOP DETECTOR PLANS & DETAILS
135 - 136	HIGHWAY LIGHTING NOTES, DEMOLITION & SYMBOLS
137 - 138	HIGHWAY LIGHTING PLAN & DETAILS
139	PULLBOX & COVER DETAILS
140 - 145	ELECTRICAL GENERAL NOTES & DEMOLITION PLANS
146 - 149	TRAFFIC SIGNAL PULLBOX DETAILS
150 - 153	ROADWAY LIGHTING GENERAL NOTES & DETAILS
154 - 168	CROSS SECTIONS

HWY-D
DESIGNED BY

HWY-DD
MANAGED BY

692-7570
PHONE

Dec. 2006
DATE

STATE OF HAWAII

DEPARTMENT OF TRANSPORTATION

HIGHWAYS DIVISION

HONOLULU, HAWAII

"AS-BUILT"

PLANS FOR

INTERSTATE ROUTE H-2 REHABILITATION


WAIPIO INTERCHANGE & MILILANI INTERCHANGE

ON/OFF RAMPS, KA UKA BLVD AND MEHEULA PKWY OVERPASSES,

& KIPAPA STREAM BRIDGE


FEDERAL AID PROJECT NO. IM-H2-1(33)

DISTRICT OF EWA
ISLAND OF OAHU

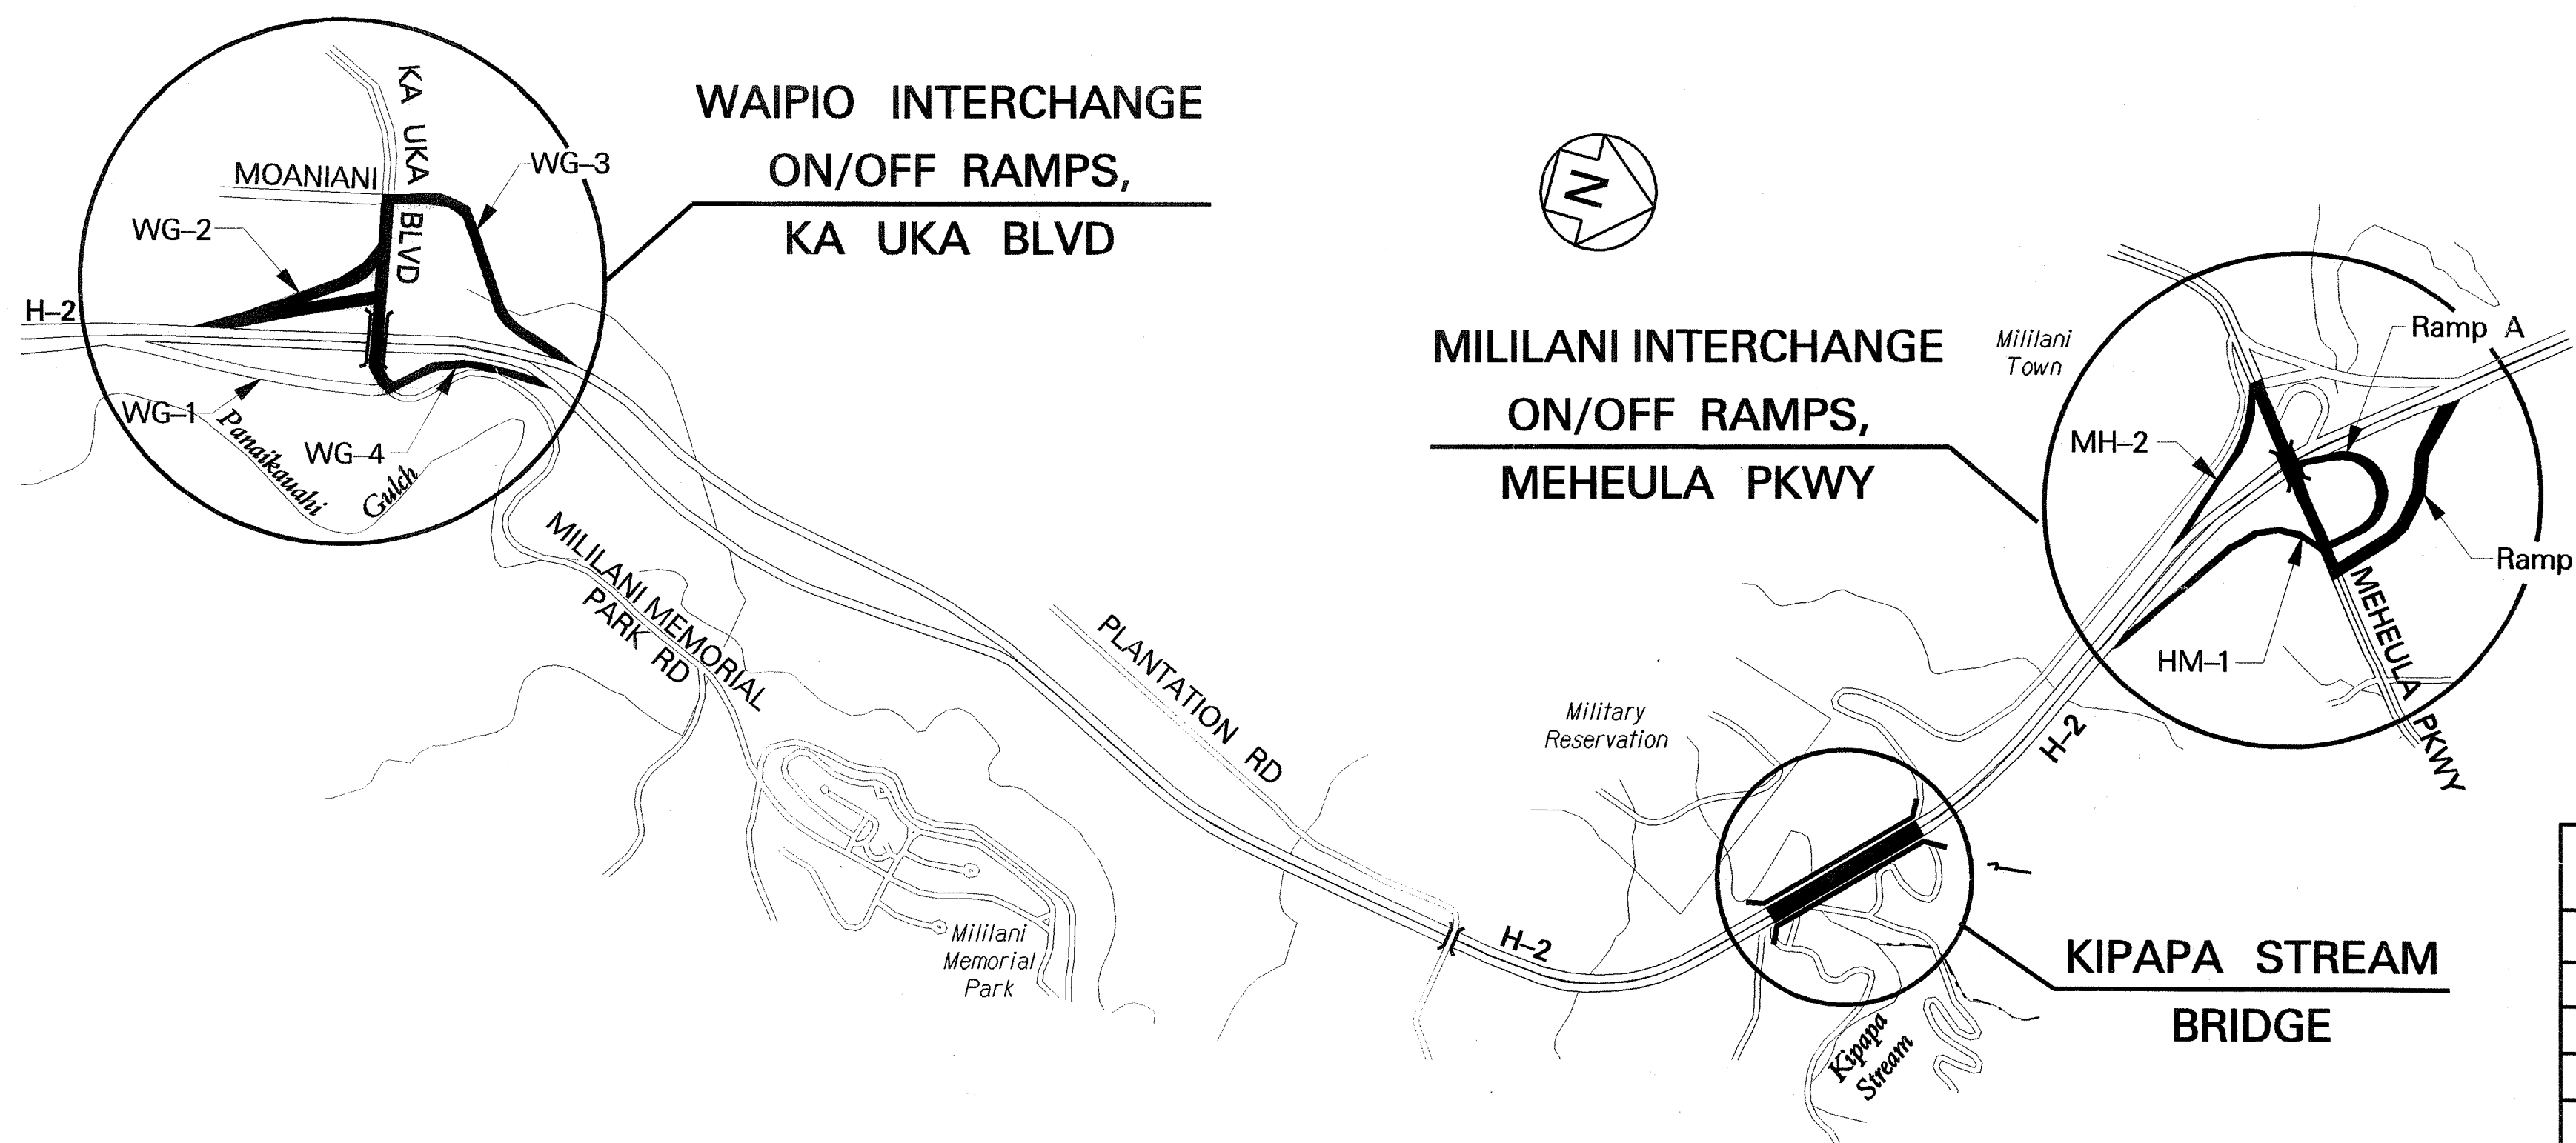

LOCATION PLAN

GROSS LENGTH OF PROJECT..... 4.12 MILES



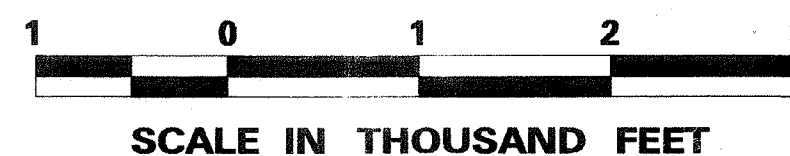


CHANGES MADE DURING CONSTRUCTION HAVE BEEN INCORPORATED ON THESE PLANS EXCEPT CHANGES IN THE ORIGINAL THEORETICAL QUANTITIES. FOR ACTUAL QUANTITIES, REFER TO PROJECT LEDGER AND/OR COMPUTATION BOOK.

RESIDENT ENGINEER

DATE

FED. ROAD DIST. NO.	STATE	FED. AID PROJ. NO.	FISCAL YEAR	SHEET NO.	TOTAL SHEETS
HAWAII	HAW.	IM-H2-1(33)	2007	1	168

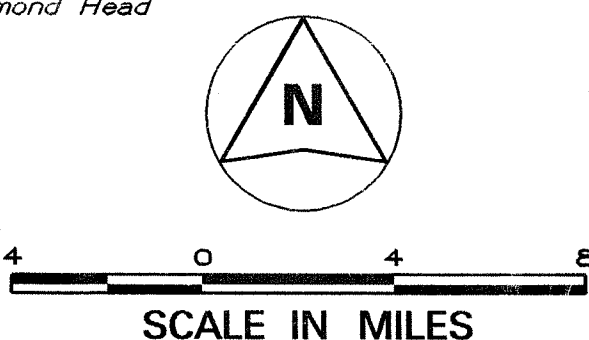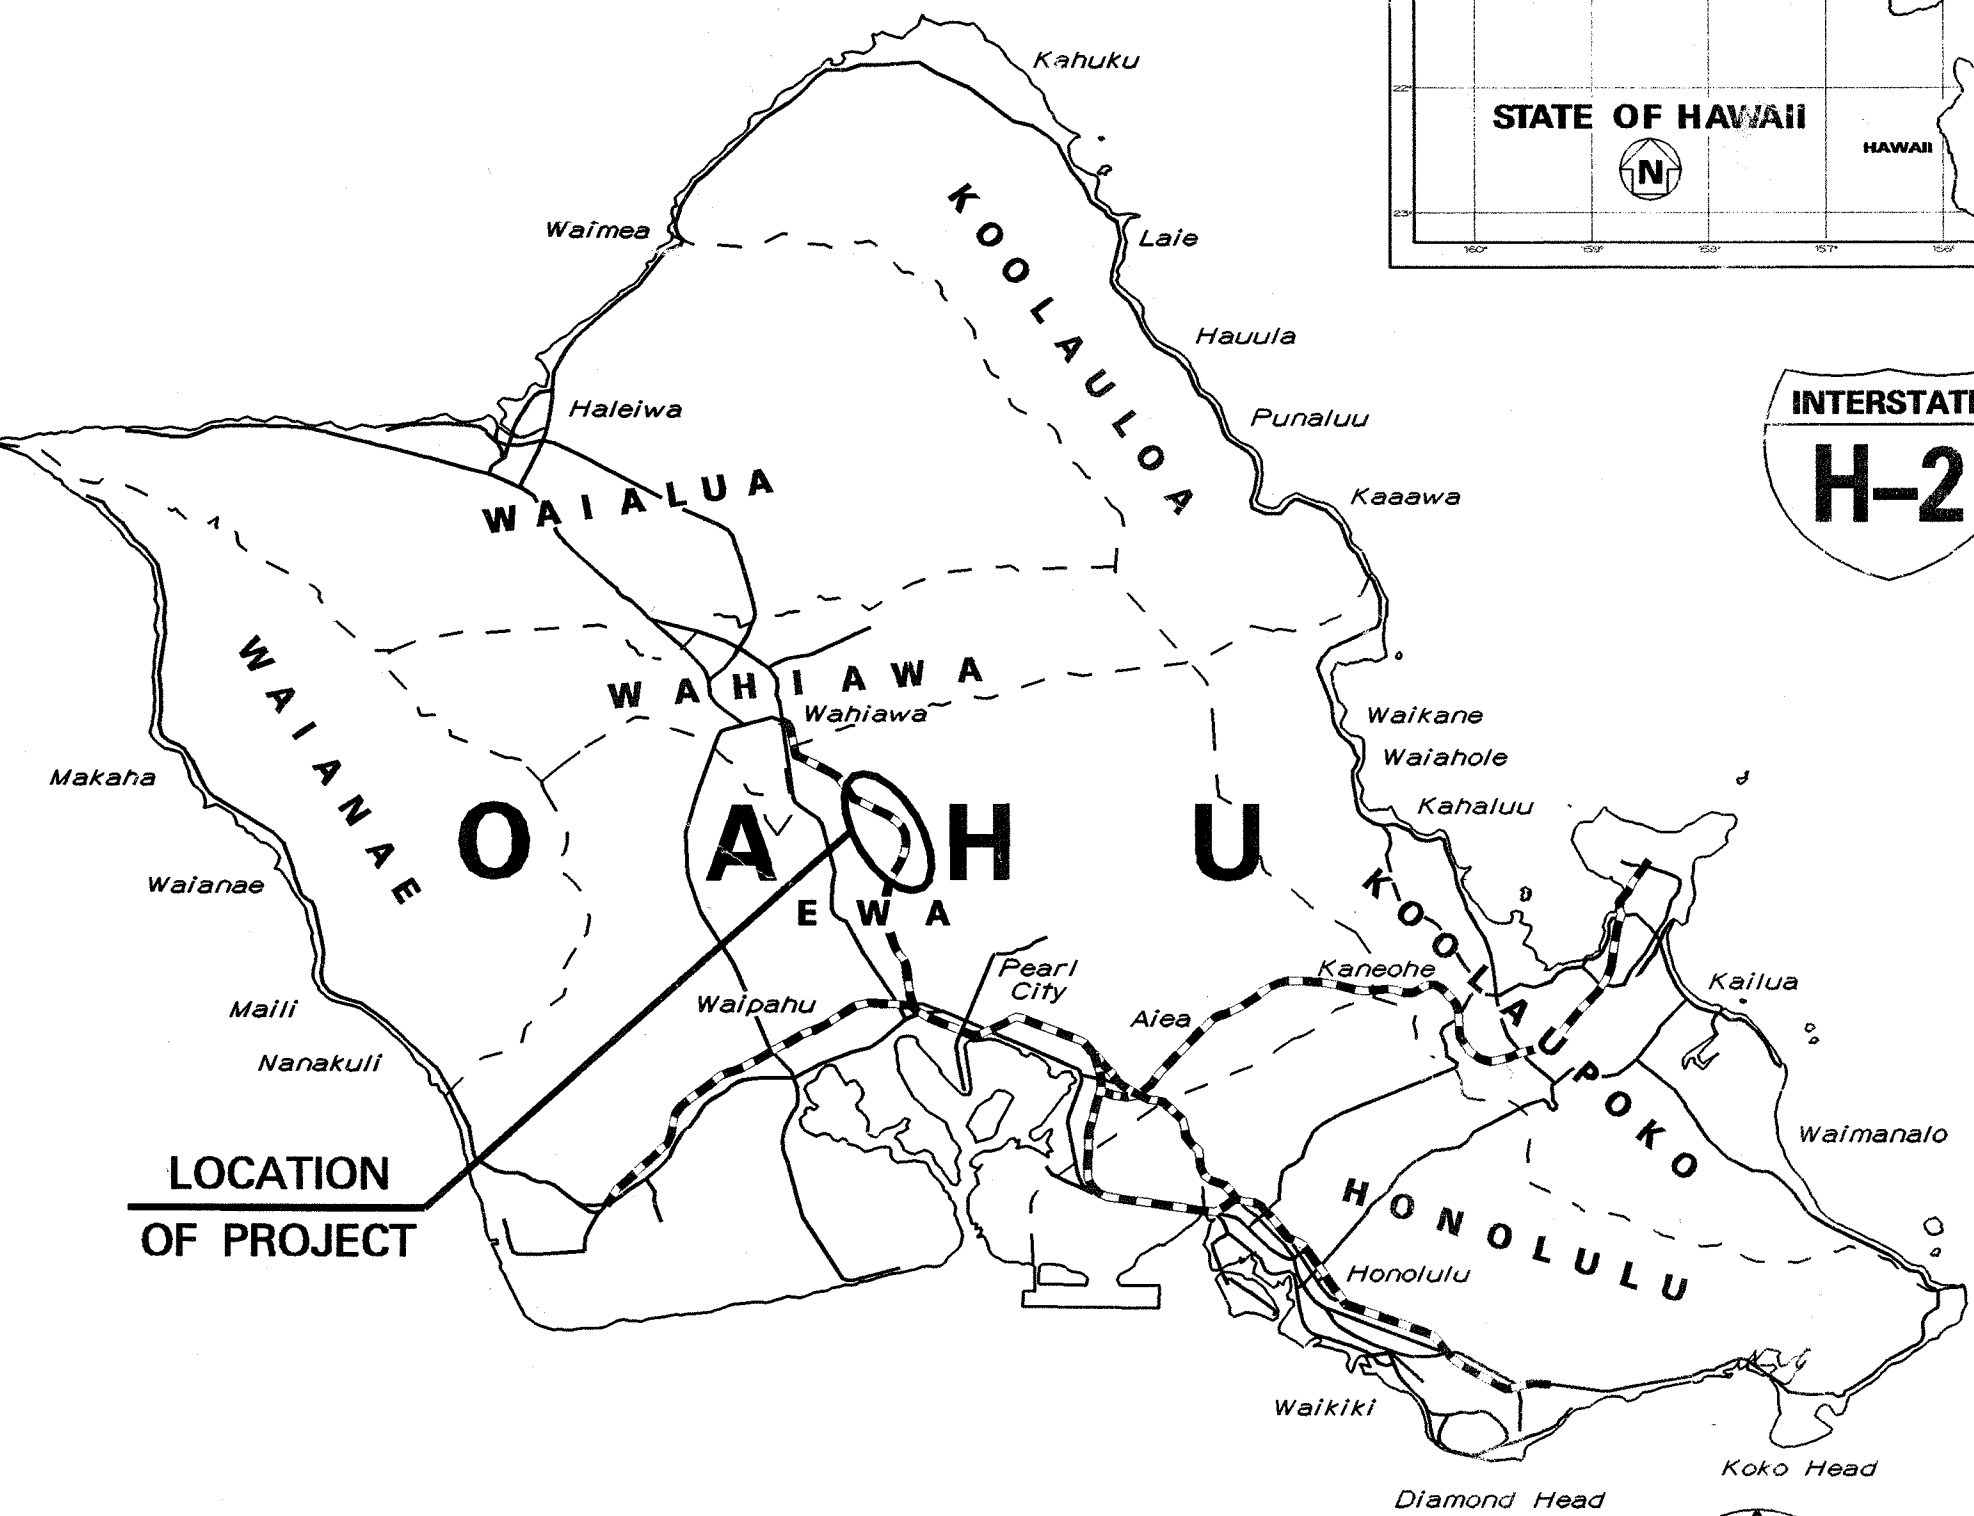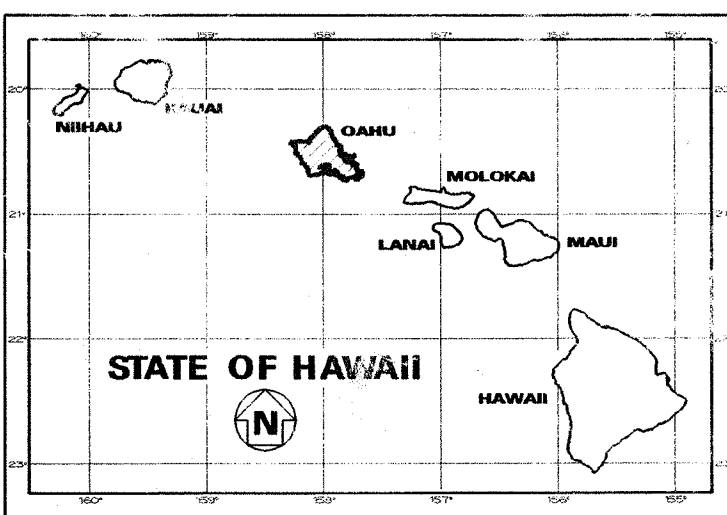

FEDERAL AID INTERSTATE PROJECTS PREVIOUSLY CONSTRUCTED OR UNDER CONSTRUCTION

MILE POST 1.88 TO MILE POST 6.00

DESIGN DESIGNATION

	Waipio Interchange	Kipapa Bridge	Mililani Interchange
ADT (2005)	18,100	86,200	22,500
ADT (2015)	19,800	94,100	24,500
DHV	1,580	7,060	2,200
D	65/35	60/40	65/35
T	1.50 %	1.50 %	3.50 %
T ₂₄	3.0 %	2.5 %	2.0 %
V	70 M.P.H.	70 M.P.H.	70 M.P.H.

DEPARTMENT OF TRANSPORTATION
STATE OF HAWAII

APPROVED:

12-11-06
DATE