


FED. ROAD DIST. NO.	STATE	PROJ. NO.	FISCAL YEAR	SHEET NO.	TOTAL SHEETS
HAWAII	HAW.	HWY-0-03-05MR	2008	4	38

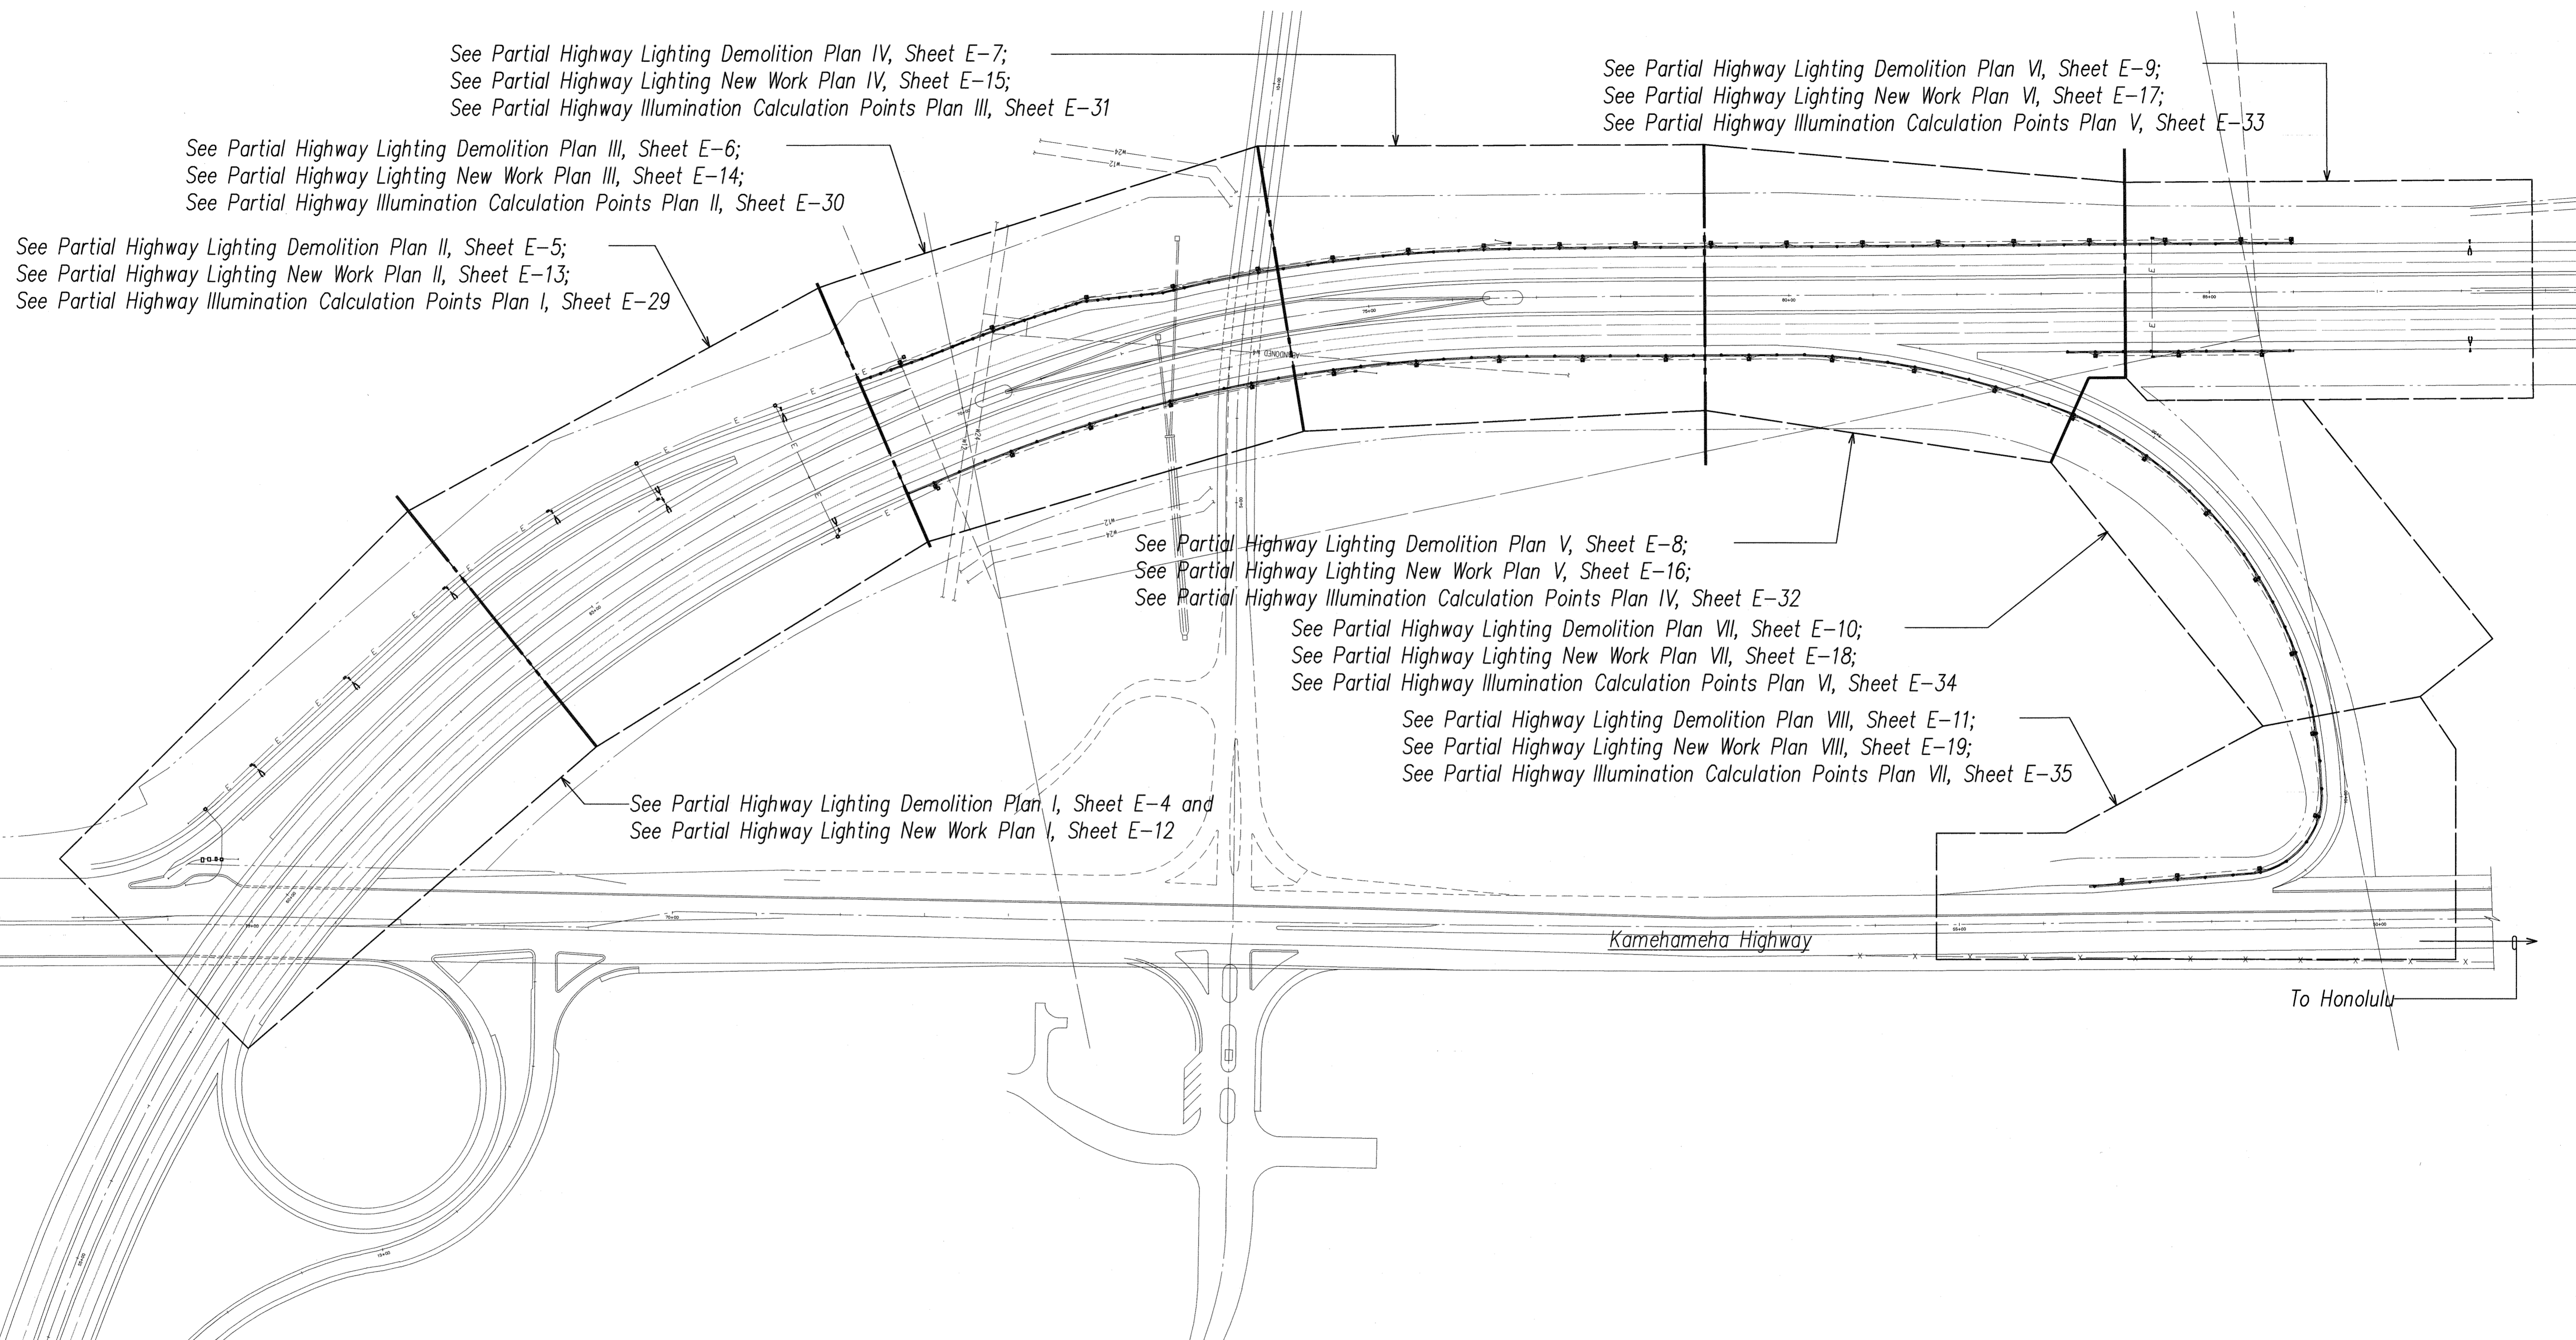

See Partial Highway Lighting Demolition Plan IV, Sheet E-7;
 See Partial Highway Lighting New Work Plan IV, Sheet E-15;
 See Partial Highway Illumination Calculation Points Plan III, Sheet E-31

See Partial Highway Lighting Demolition Plan III, Sheet E-6;
 See Partial Highway Lighting New Work Plan III, Sheet E-14;
 See Partial Highway Illumination Calculation Points Plan II, Sheet E-30

See Partial Highway Lighting Demolition Plan II, Sheet E-5;
 See Partial Highway Lighting New Work Plan II, Sheet E-13;
 See Partial Highway Illumination Calculation Points Plan I, Sheet E-29

See Partial Highway Lighting Demolition Plan VI, Sheet E-9;
 See Partial Highway Lighting New Work Plan VI, Sheet E-17;
 See Partial Highway Illumination Calculation Points Plan V, Sheet E-33

See Partial Highway Lighting Demolition Plan V, Sheet E-8;
 See Partial Highway Lighting New Work Plan V, Sheet E-16;
 See Partial Highway Illumination Calculation Points Plan IV, Sheet E-32

See Partial Highway Lighting Demolition Plan VII, Sheet E-10;
 See Partial Highway Lighting New Work Plan VII, Sheet E-18;
 See Partial Highway Illumination Calculation Points Plan VI, Sheet E-34

See Partial Highway Lighting Demolition Plan VIII, Sheet E-11;
 See Partial Highway Lighting New Work Plan VIII, Sheet E-19;
 See Partial Highway Illumination Calculation Points Plan VII, Sheet E-35

See Partial Highway Lighting Demolition Plan I, Sheet E-4 and
 See Partial Highway Lighting New Work Plan I, Sheet E-12



Kamehameha Highway

To Honolulu

ORIGINAL PLAN	DATE
DRAWN BY	
TRACED BY	
DESIGNED BY	
QUANTITIES BY	
CHECKED BY	
No.	

LAST SAVE: 06/23/07 @ 05:52:31 BY: AM PL07 SC: 1=100
 Z:\ROAD\PROJECTS\24056A\W00L_24056A_overall site plan.dwg

OVERALL ELECTRICAL SITE PLAN
 SCALE: 1"=100'

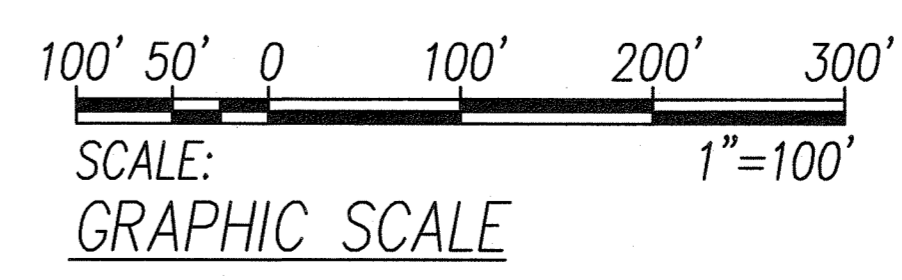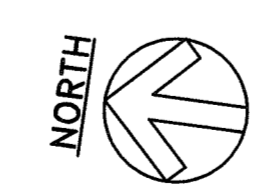

RONALD N. S. HO & ASSOCIATES, INC.
 Electrical Engineers

ANDREW I. MIYASATO
 LICENSED PROFESSIONAL ENGINEER
 No. 4340-E
 HAWAII, U.S.A.

05.22.08
Andrew I. Miyasato

THIS WORK WAS PREPARED BY ME OR UNDER MY SUPERVISION

04.30.2008
 EXPIRATION DATE OF THE LICENSE

STATE OF HAWAII
 DEPARTMENT OF TRANSPORTATION
 HIGHWAYS DIVISION

OVERALL ELECTRICAL SITE PLAN

H-2 RAIL LIGHT REPLACEMENT,
 VICINITY OF WAHIAWA OFF RAMP

Project No. HWY-0-03-05MR
 Scale: AS NOTED Date: MAY 2008

SHEET No. E-3 OF 35 SHEETS