



FED. ROAD DIST. NO.	STATE	PROJ. NO.	FISCAL YEAR	SHEET NO.	TOTAL SHEETS
HAWAII	HAW.	HWY-O-03-05MR	2008	1	38

INDEX TO DRAWINGS	
SHEET NO.	DESCRIPTION
1	TITLE SHEET
2	ELECTRICAL SYMBOLS
3	CONSTRUCTION NOTES
4	OVERALL ELECTRICAL SITE PLAN
5-12	HIGHWAY LIGHTING DEMOLITION PLANS
13-20	HIGHWAY LIGHTING NEW WORK PLANS
21	ENLARGED ELECTRICAL PLANS
22	DUCT SECTION DETAILS
23	TYPICAL ENLARGED PLAN FOR WIRING TO HIGHWAY LIGHTS
24	TYPICAL ELEVATIONS FOR WIRING TO HIGHWAY LIGHTS
25	LOW LEVEL HIGHWAY LIGHT FIXTURE DETAILS
26	BARRIER MOUNTED LOW LEVEL HIGHWAY LIGHT FIXTURE DETAILS
27-29	HIGHWAY LIGHTING WIRING DIAGRAMS
30-36	HIGHWAY ILLUMINATION CALCULATION POINTS PLANS
37	MOUNTING DETAILS FOR LOW LEVEL LIGHT FIXTURE
38	FREEWAY WORK ZONE SIGNING PLAN, NOTES & DETAILS

STATE OF HAWAII
DEPARTMENT OF TRANSPORTATION
HIGHWAYS DIVISION
HONOLULU, HAWAII
"AS-BUILT"
PLANS FOR
**H-2 RAIL LIGHTING REPLACEMENT
VICINITY OF WAHIAWA OFF RAMP**

PROJECT NO. HWY-O-03-05MR

DISTRICT OF WAHIAWA
ISLAND OF OAHU

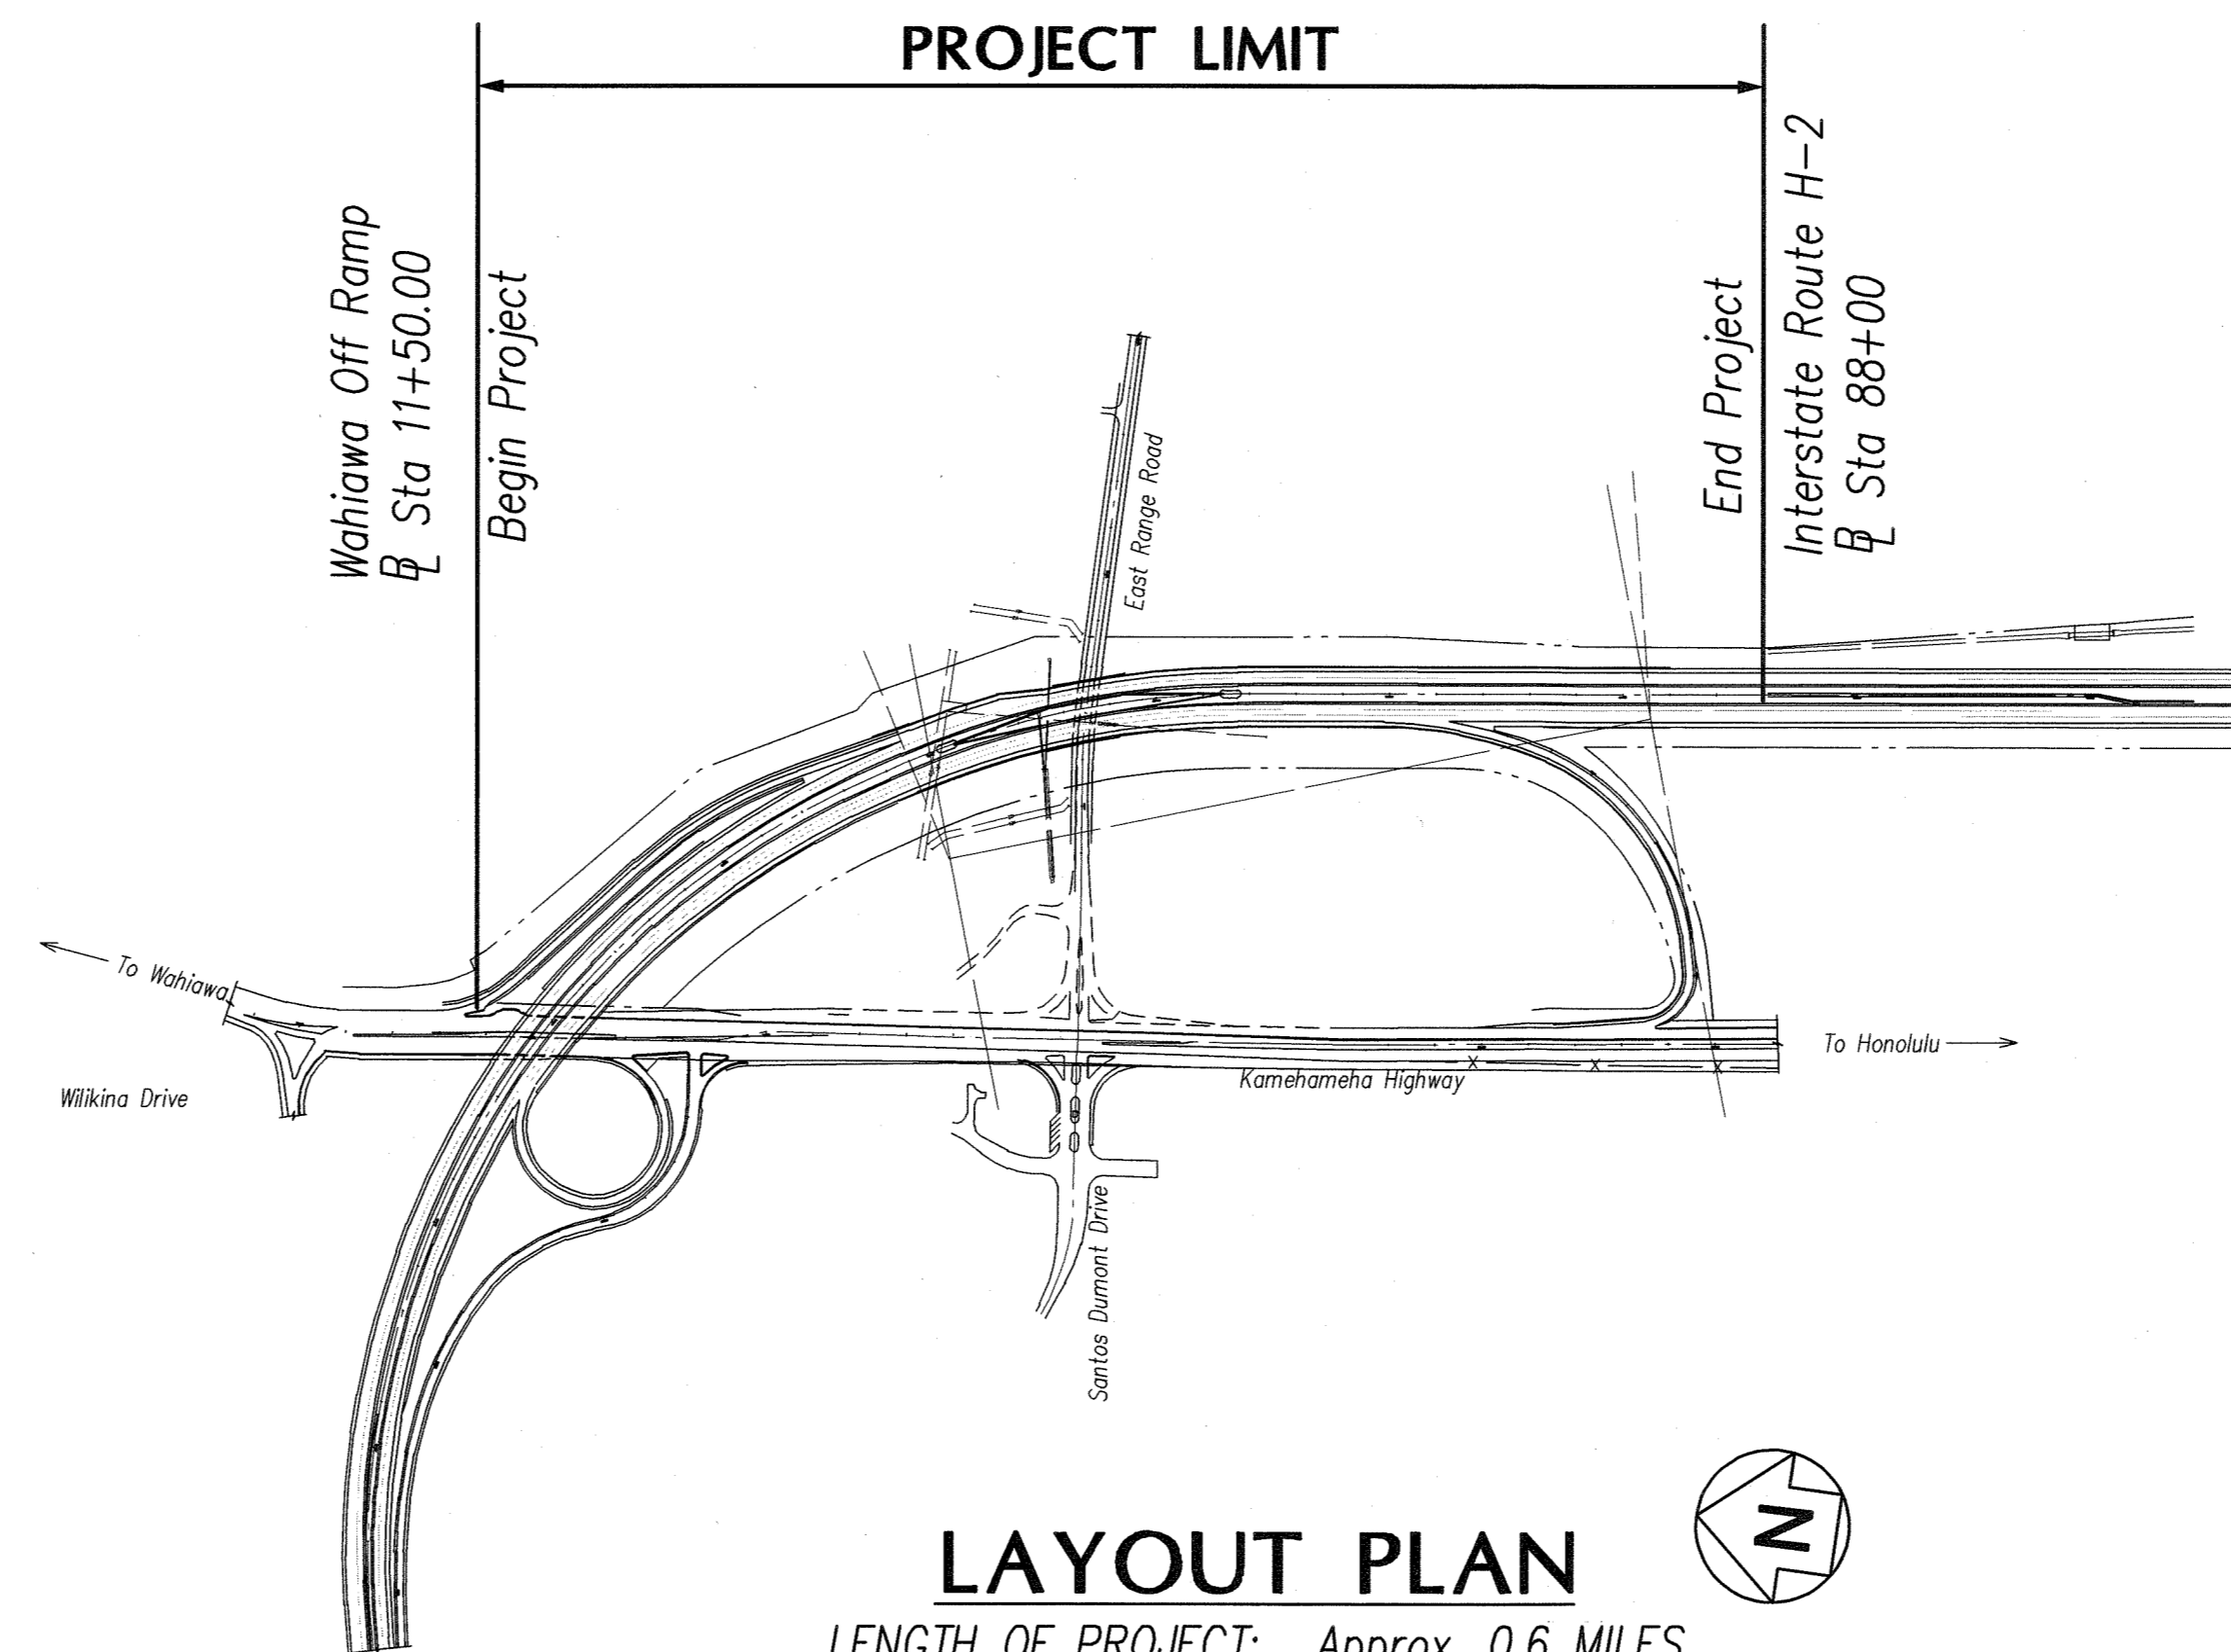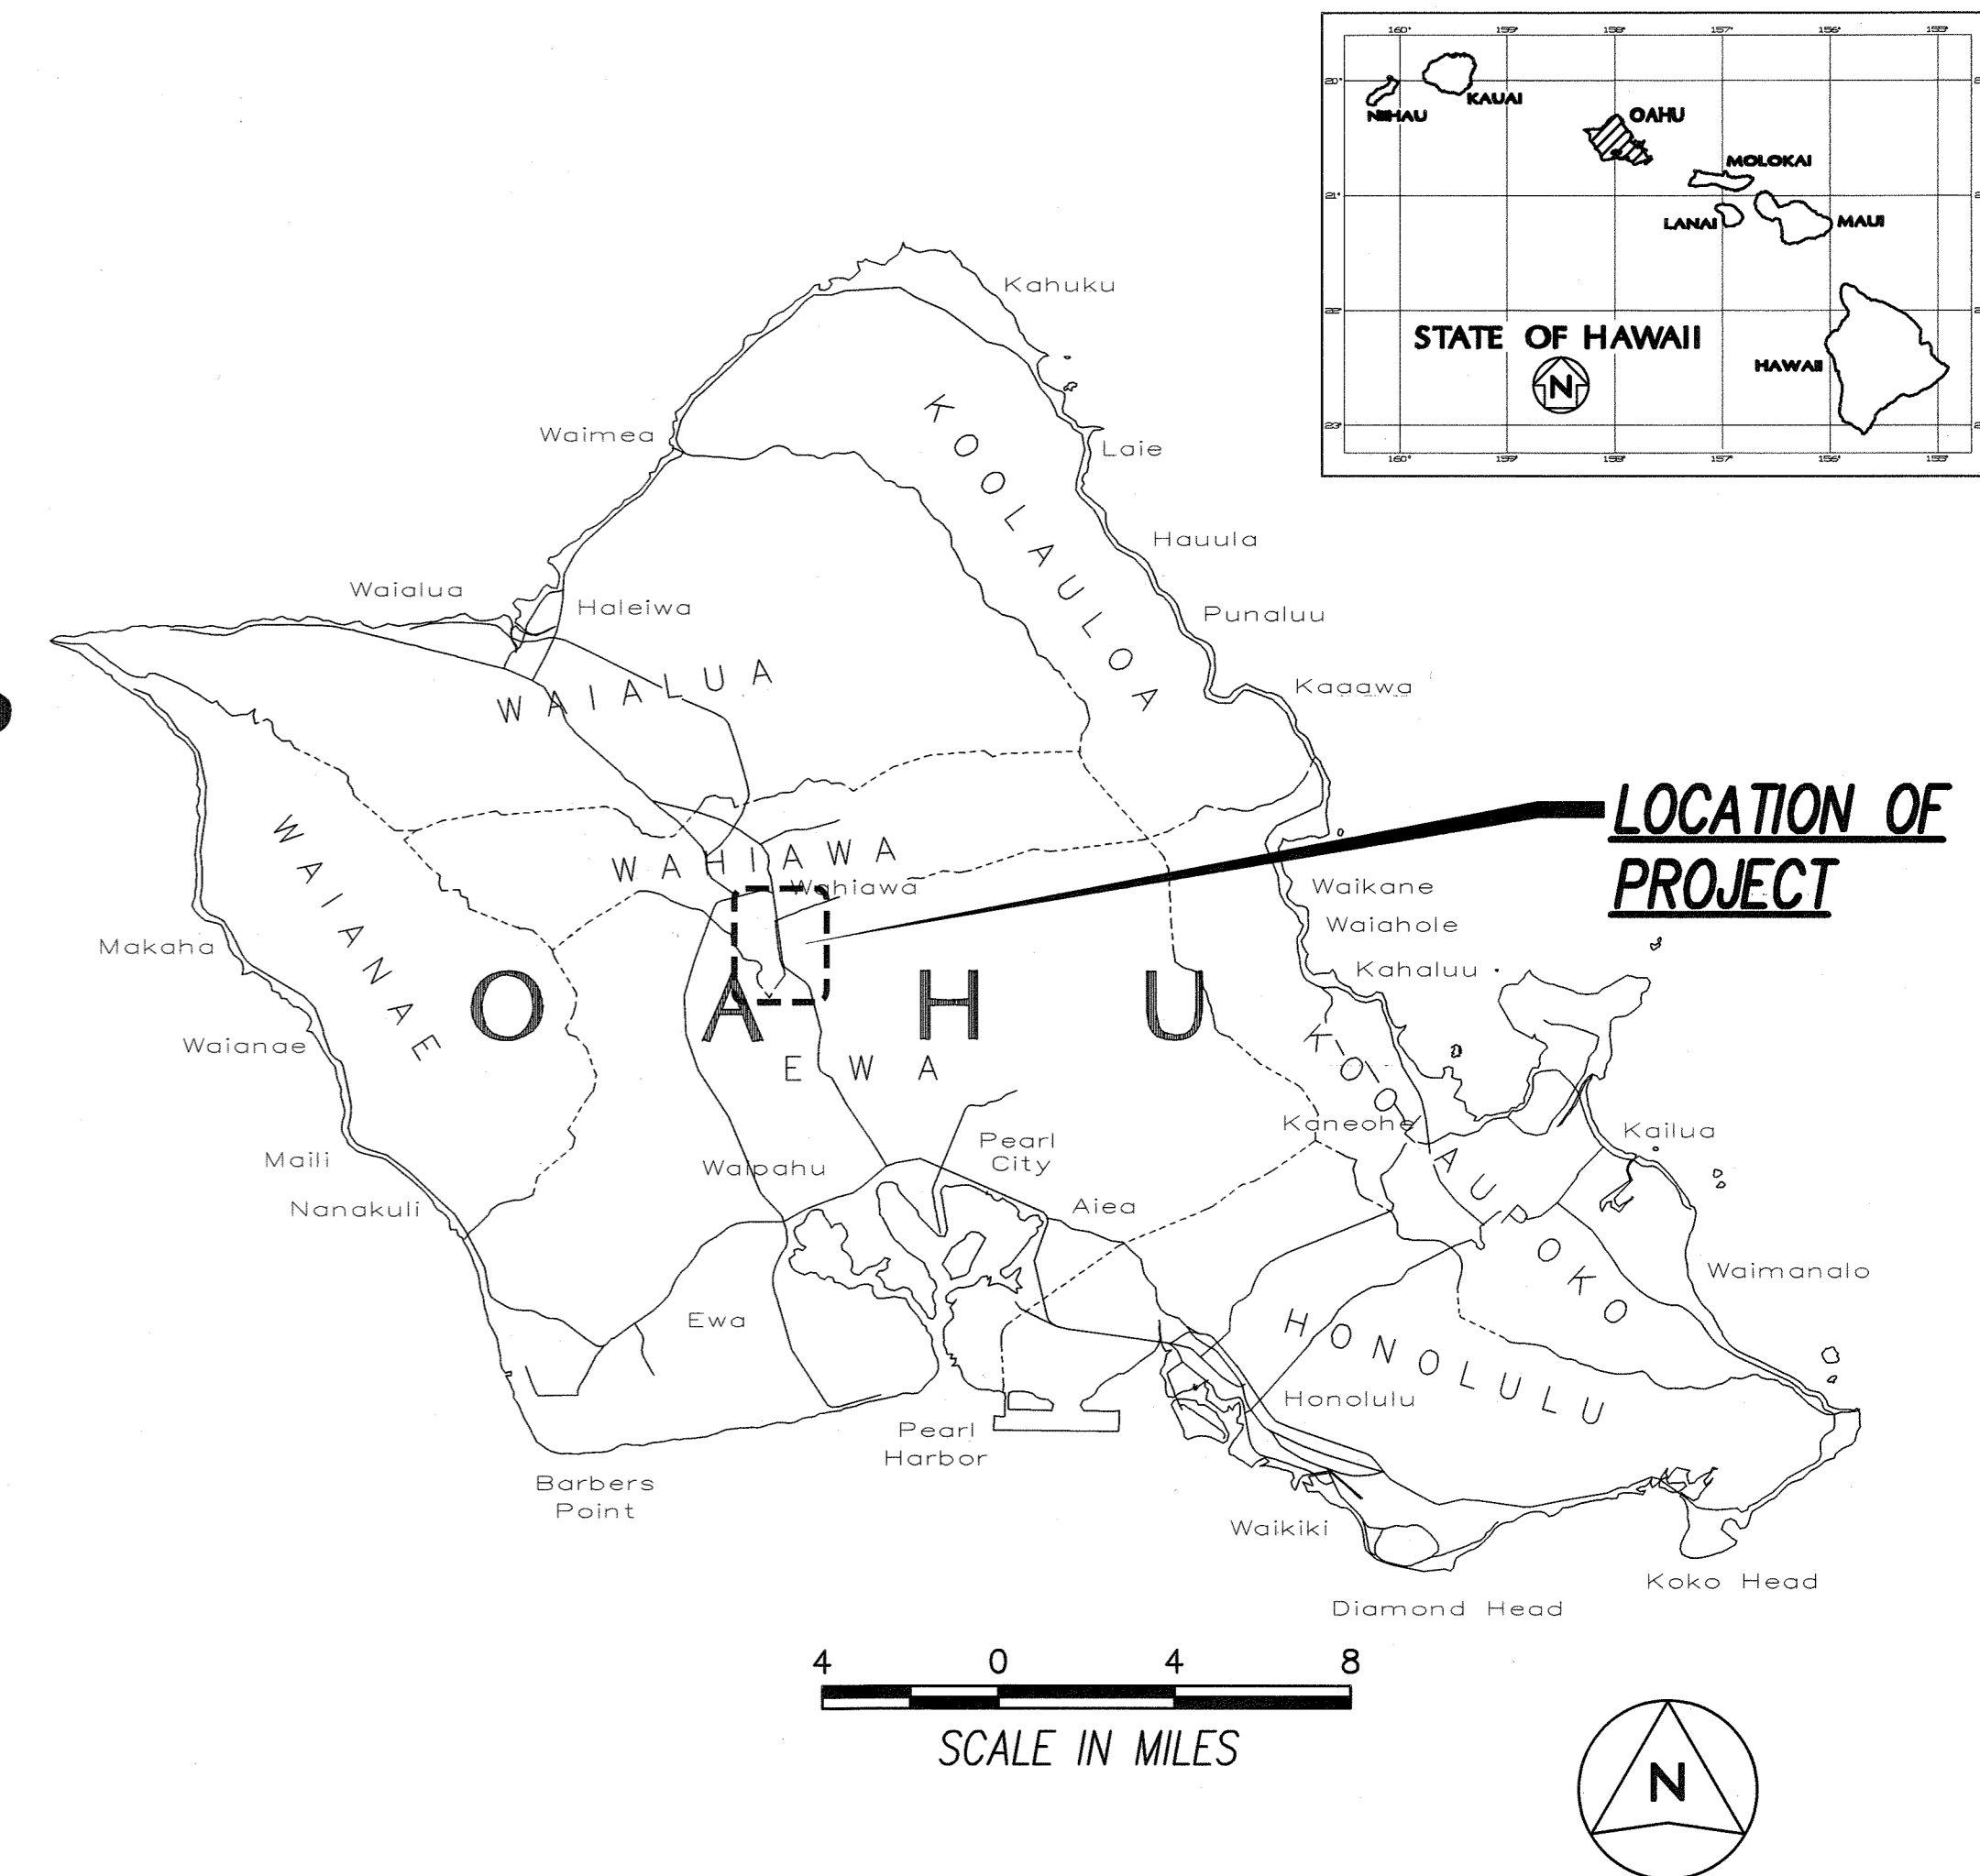

LAYOUT PLAN
LENGTH OF PROJECT: Approx. 0.6 MILES

CHANGES MADE DURING CONSTRUCTION HAVE BEEN INCORPORATED ON THESE PLANS EXCEPT CHANGES IN THE ORIGINAL THEORETICAL QUANTITIES. FOR ACTUAL QUANTITIES/ REFER TO PROJECT LEDGER AND/OR QUANTITY BOOK.

[Signature] 4/26/08
RESIDENT ENGINEER DATE

DEPARTMENT OF TRANSPORTATION
STATE OF HAWAII

APPROVED:
[Signature] 5.22.08
DIR. OF TRANSPORTATION DATE

ORIGINAL PLAN SURVEY PLOTTED BY: _____ DATE: _____
DRAWN BY: _____
NOTE BOOK TRACKED BY: _____
DESIGNED BY: _____ QUANTITIES BY: _____
CHECKED BY: _____

LAST SAVE: 05/21/08 @ 08:34:01 BY: AM PLOT 50, 1=400
Z:\ACAD\PROJECTS\24056A\1001_24056A.dwg 24056A.dwg

DESIGNED BY: Ronald N. S. Ho & Assoc., Inc. HWY-TD 692-7679 PHONE 692-7679 DATE May, 2008