


FED. ROAD DIST. NO.	STATE	FED. AID PROJ. NO.	FISCAL YEAR	SHEET NO.	TOTAL SHEETS
HAWAII	HAW.	U-FF-078-1(6)	1976	79	142

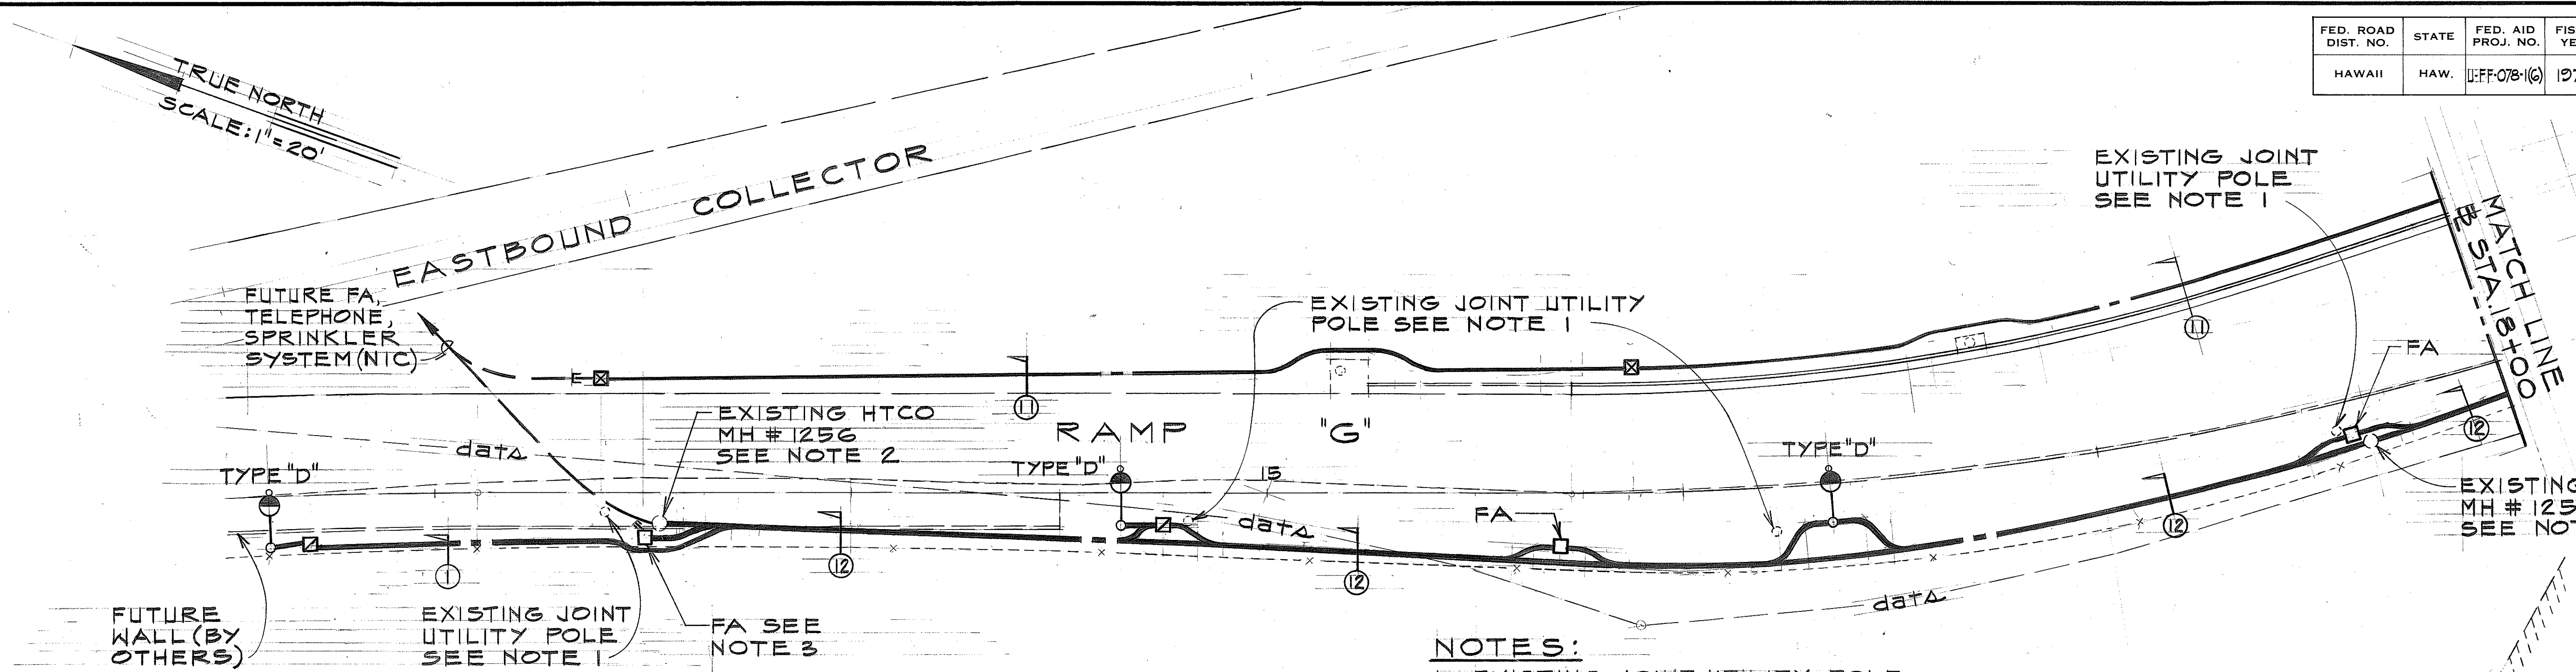



- NOTES:**
- EXISTING JOINT UTILITY POLE:
 - EXISTING JOINT UTILITY POLE & HTCO OH LINE TO BE REMOVED BY HTCO, (N.I.C.)
 - REMOVE EXISTING OH SERIES STREET LIGHT & OH FIRE ALARM SYSTEM.
 - EXTEND 2-4" HTCO DUCT INTO EXISTING HTCO MANHOLE OR TYPE I HANDHOLE AS SHOWN ON PLAN.
 - EXTEND EXISTING FA DUCT INTO FA PULLBOX

APPROVED BY:

C. J. Muench 7-13-76
HAWAIIAN ELECTRIC CO., INC. DATE

J. De la Cruz 7-8-76
HAWAIIAN TELEPHONE CO. DATE

R. Kamm 7-7-76
DEPT. OF TRANSPORTATION SERVICES DATE
CITY & COUNTY OF HONOLULU
MUNICIPAL FIRE ALARM CIRCUIT RELOCATION CLEARANCE

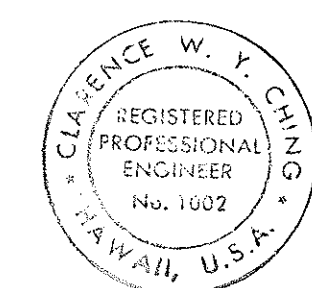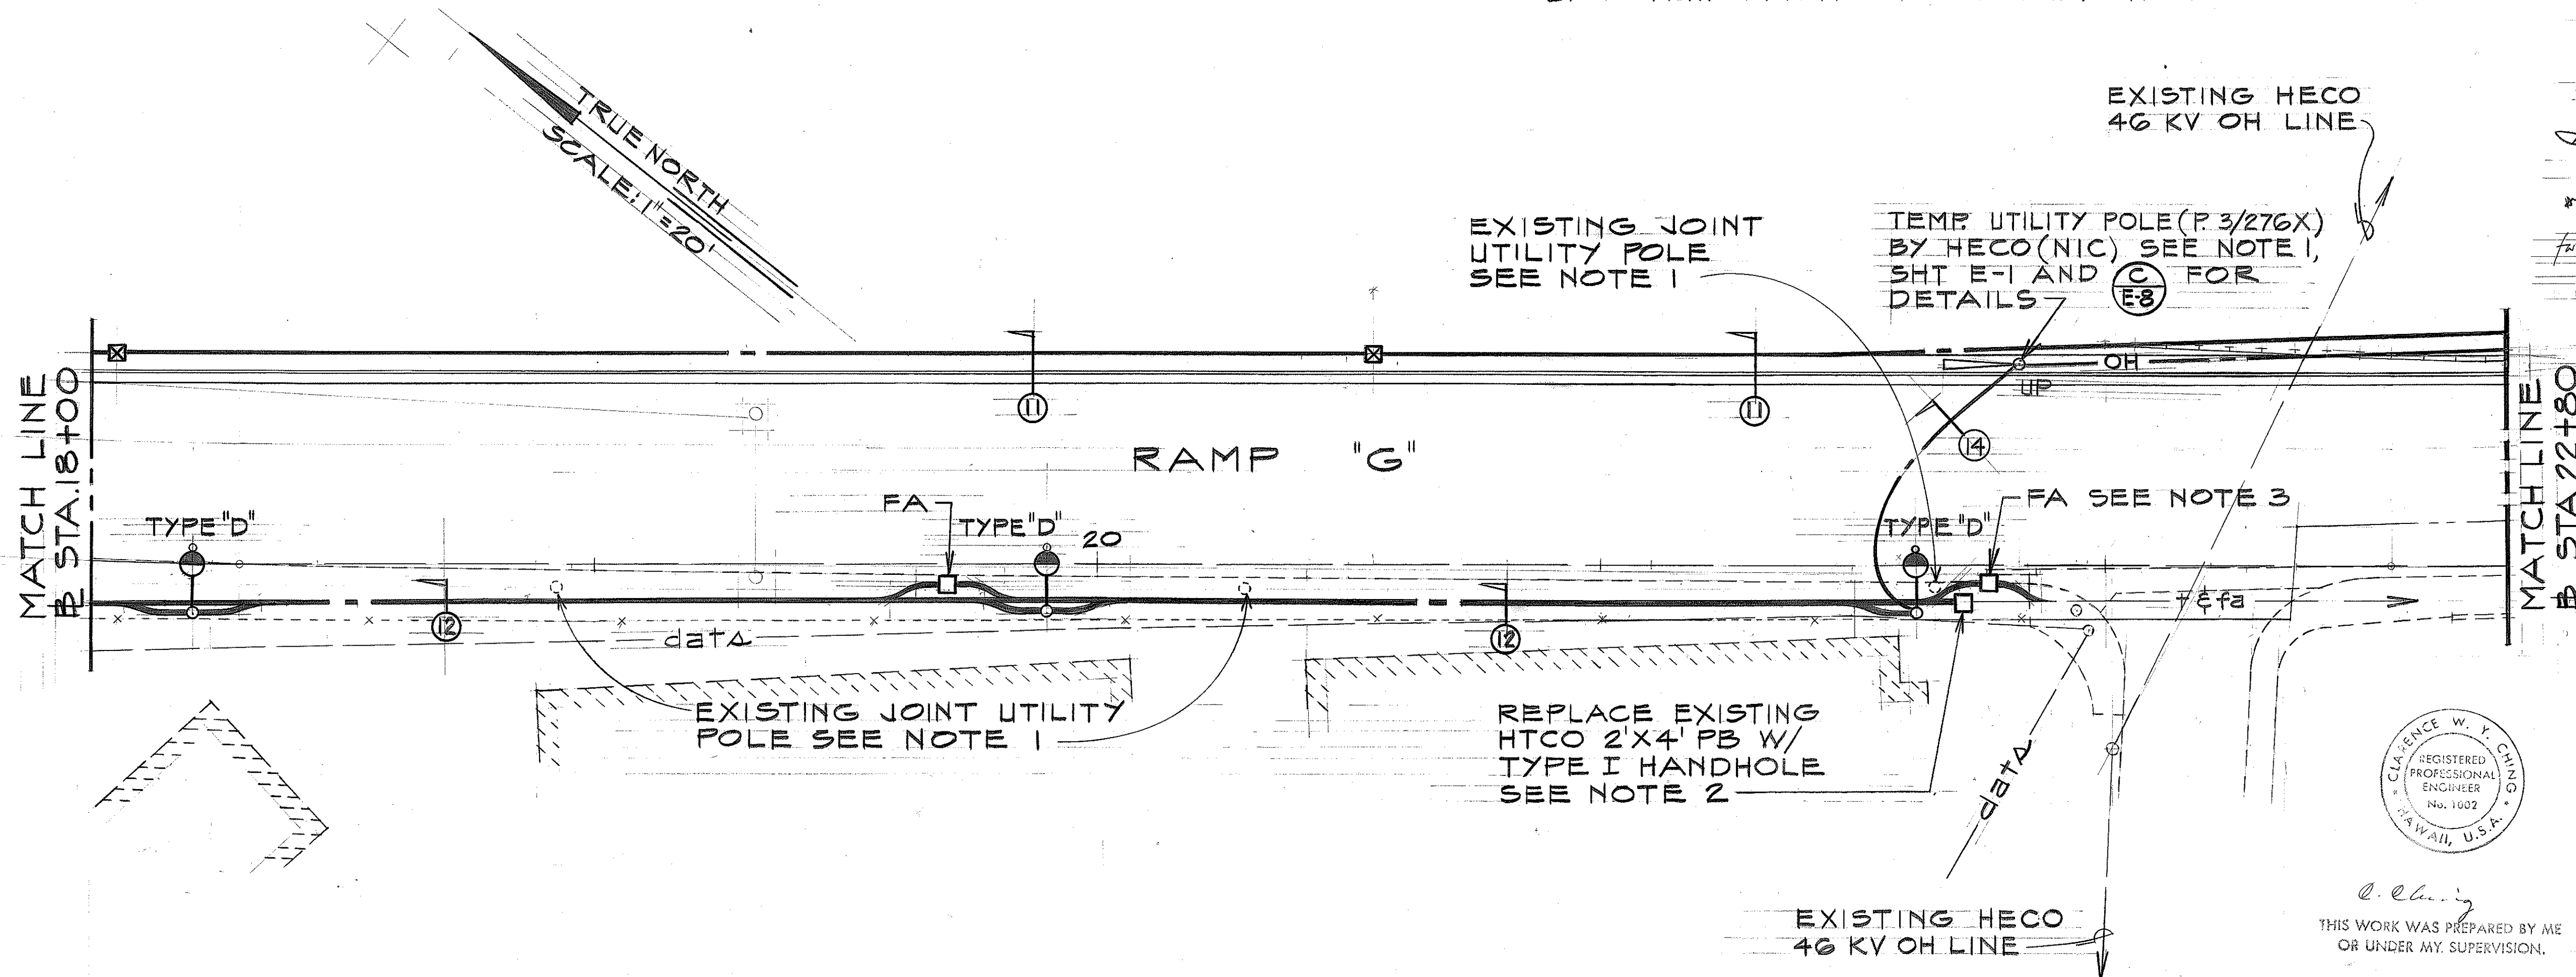

THIS WORK WAS PREPARED BY ME OR UNDER MY SUPERVISION.

STATE OF HAWAII
DEPARTMENT OF TRANSPORTATION
HIGHWAYS DIVISION

ELECTRICAL PLAN

MOANALUA ROAD
PUULOA I.C. TO MIDDLE ST.-UNIT I
FA. Proj. No. U-FF-078-1(6)

SCALE: AS SHOWN DATE: JUNE 25, 1976
SHEET NO. E-2 OF 18 SHEETS

SURVEY PLOTTED BY	DATE
DRAWN BY	
CHECKED BY	
DESIGNED BY	
QUANTITIES BY	
NOTED BY	
CHECKED BY	

