

INDEX TO DRAWINGS	
SHEET NO.	DESCRIPTION
1	TITLE SHEET
2 - 5	BORING PLAN & LOGS
6 - 7	CONSTRUCTION PHASING
8 - 9	TYPICAL ROADWAY SECTION
10 - 13	ALIGNMENT PLAN
14 - 17	PROFILES & SUPERELEVATION DIAGRAMS
18 - 25	DETAIL PLAN OF ROADWAY
26	MOANALUA STREAM LINING
27	MISCELLANEOUS DETAILS
28 - 29	TYPICAL DETAILS OF WHEEL CHAIR RAMPS
30 - 42	STANDARD DETAILS
43 - 49	DRAINAGE & GRADING PLAN
50 - 52	DRAINAGE PROFILES
53 - 55	DRAINAGE SUMMARY
56 - 65	DRAINAGE DETAILS
66 - 71	CONSTRUCTION DETOUR PLANS
72 - 77	CONSTRUCTION DETOUR PLAN & DETAILS
78 - 82	SIGNING & PAVEMENT MARKING PLAN
83 - 86	PANEL & FRAME LAYOUT
87 - 113	SIGNING DETAILS
114 - 119	PLANTING PLAN
120 - 130	SPRINKLER SYSTEM
131 - 132	UTILITY GENERAL NOTES
133 - 137	UTILITY RELOCATION PLAN
138 - 140	UTILITY RELOCATION PROFILES
141 - 143	MANHOLE & HANDHOLE DETAILS
144 - 154	UTILITY DETAILS
155 - 166	ELECTRICAL PLAN & DETAILS
167 - 168	INDEX TO STRUCTURAL DRAWINGS & NOTES
169 - 199	MOANALUA STREAM BRIDGES & KAUA ST. TRESTLE STRUCTURE & DETAILS
200 - 226	DAMON OVERPASS STRUCTURE & DETAILS
227 - 228	TYPICAL STRUCTURE DETAILS
229 - 247	RETAINING WALL PLAN & DETAILS
248 - 256	STANDARD STRUCTURAL DETAILS
257 - 266	CROSS SECTIONS

Plan Sht. Nos. ① CO 24 S-1, ② CO 27 S-1, ③ CO 40 S-1, ④ CO 58 S-1, ⑤ CO 129 S-1, & ⑥ CO 165 S-1 are supplementary sheets to this project.
TOTAL SHEET COUNT after "AS BUILT" postings: 272 Sheets.

11/15/78
DATE
DESIGNED BY
JAMES SUGIHARA
548-6932
PHONE
P. S. & E. BY
M&E PACIFIC, INC.

STATE OF HAWAII
DEPARTMENT OF TRANSPORTATION
LAND TRANSPORTATION FACILITIES DIVISION

HONOLULU, HAWAII
"AS - BUILT"
PLANS FOR
CONSTRUCTION OF A PORTION OF
MOANALUA ROAD
PUULOA INTERCHANGE TO MIDDLE STREET-UNIT 3A
MOANALUA STREAM TO FORT SHAFTER OVERPASS
FEDERAL AID PROJECT NO. TQF-F-078-I(18)


DISTRICT OF HONOLULU
ISLAND OF OAHU

NOTE

WHEREVER THE PROJECT NO. TQF-F-078-I(18) APPEARS IN THESE PLANS, IT SHALL BE AMENDED TO READ TQF-F-078-I(18)
DATE: 11-15-78


CHANGES MADE DURING CONSTRUCTION HAVE BEEN INCORPORATED ON THESE PLANS EXCEPT CHANGES IN THE ORIGINAL THEORETICAL QUANTITIES. FOR ACTUAL QUANTITIES, REFER TO PROJECT LEDGER AND/OR COMPUTATION BOOK.

Robert P. Nishi
RESIDENT ENGINEER
7-15-85
DATE

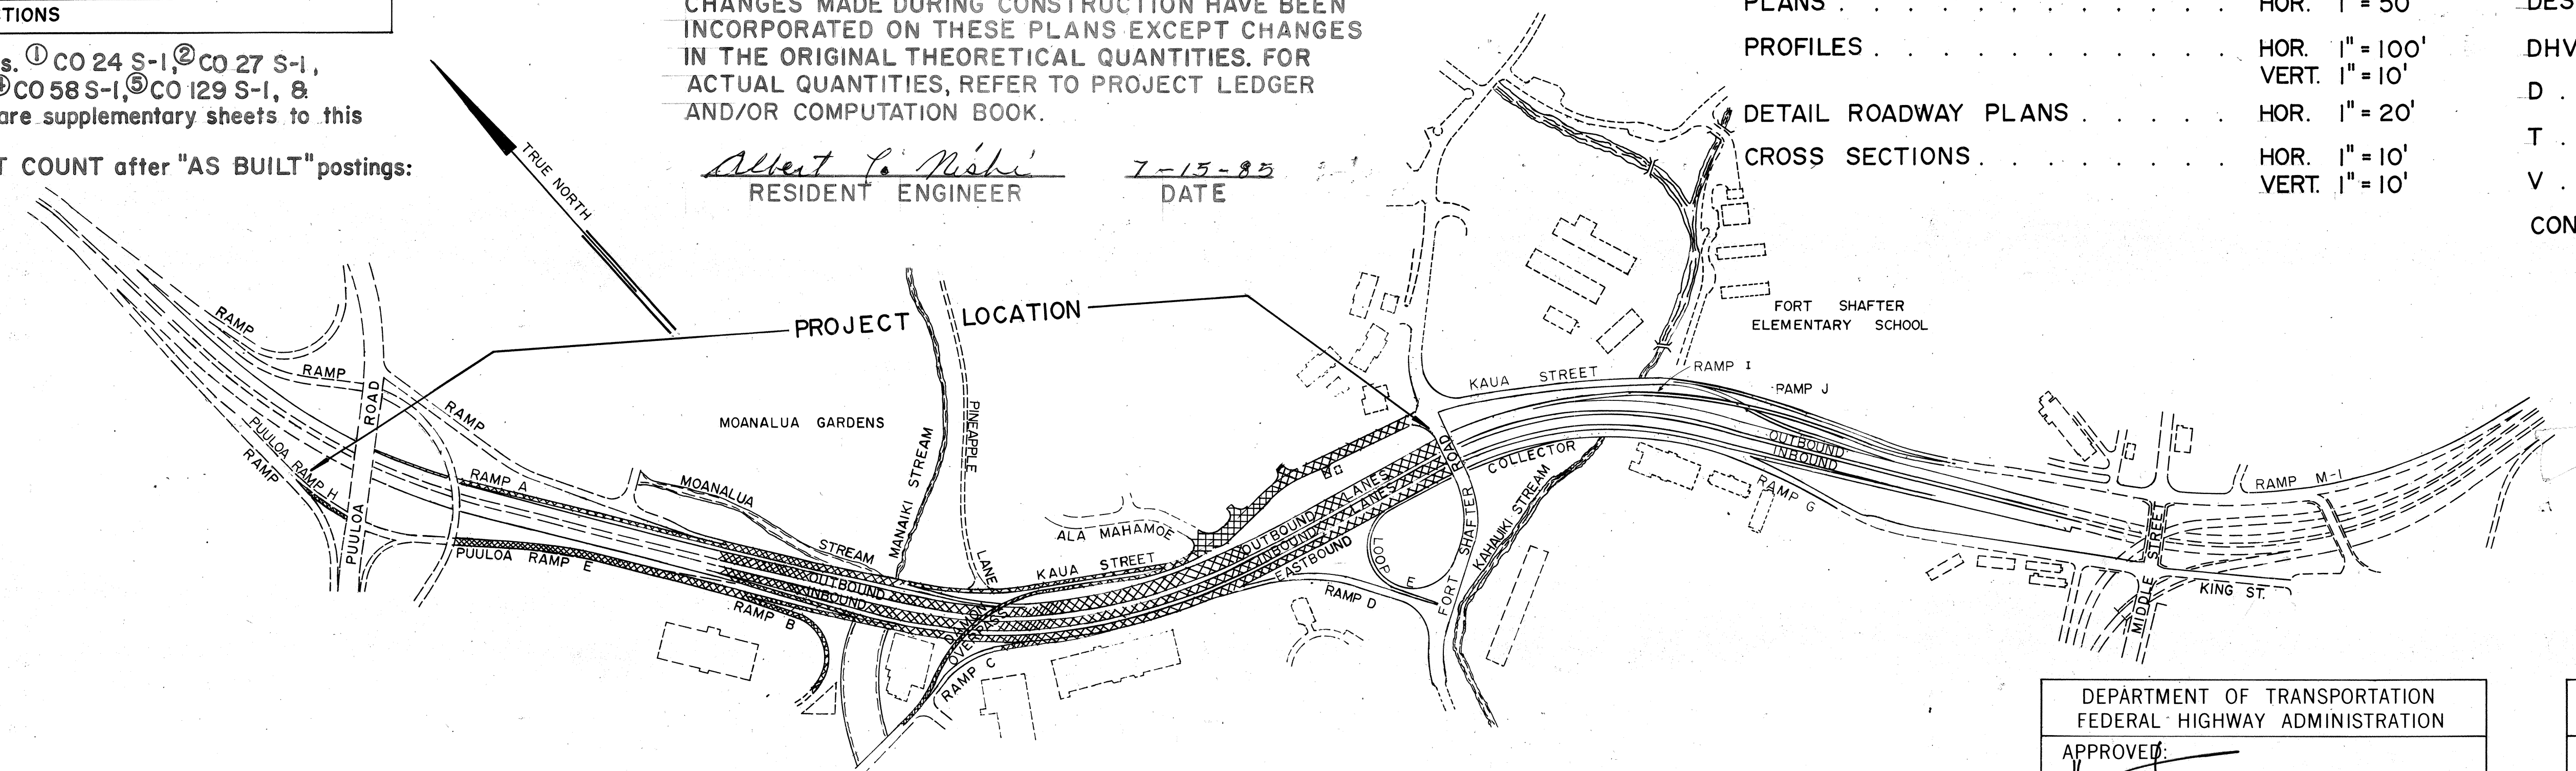

LAYOUT PLAN
SCALE: 1" = 325'

FED. ROAD DIST. NO.	STATE	FED. AID PROJ. NO.	FISCAL YEAR	SHEET NO.	TOTAL SHEETS
HAWAII	HAW.	TQF-F-078-I(18)	1978	1	266

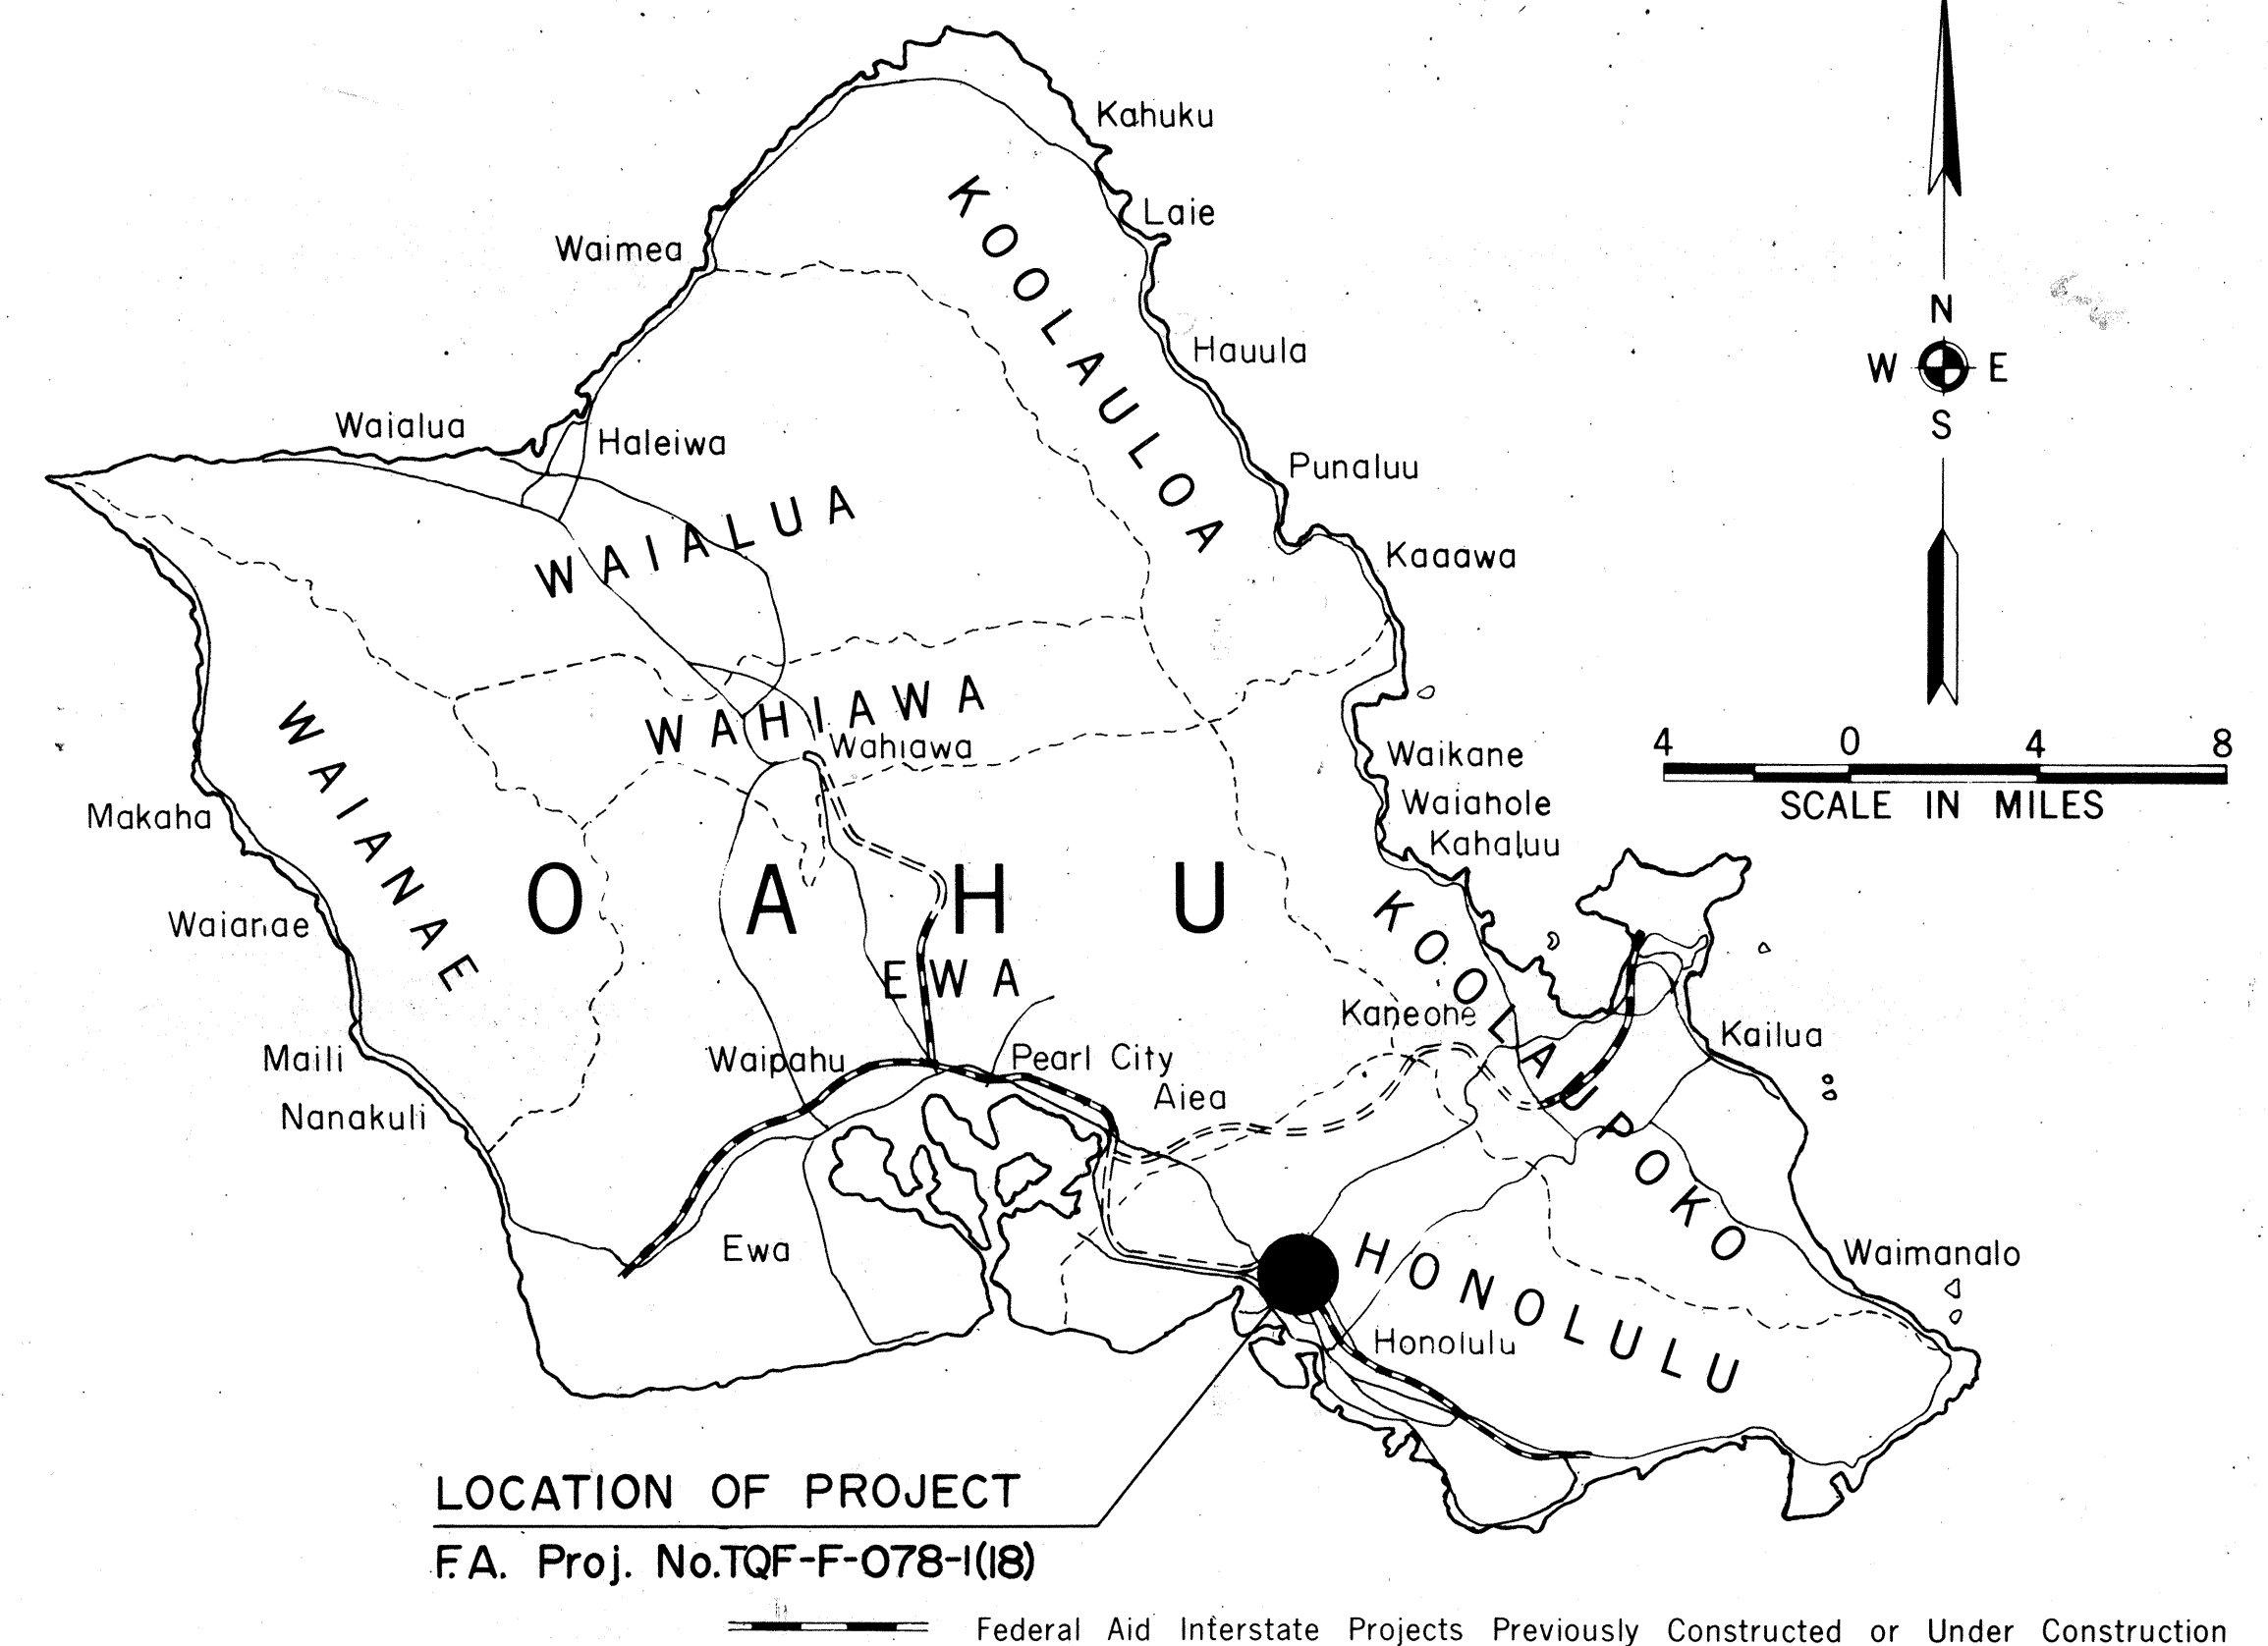

SCALES:

PLANS	HOR. 1" = 50'
PROFILES	HOR. 1" = 100'
	VERT. 1" = 10'
DETAIL ROADWAY PLANS	HOR. 1" = 20'
CROSS SECTIONS	HOR. 1" = 10'
	VERT. 1" = 10'

DESIGN DESIGNATION

CURRENT ADT (1978).	44,100
DESIGN ADT	73,900
DHV	7,840
D	60/40
T	5%
V	60 M.P.H.
CONTROL OF ACCESS .	FULL

DEPARTMENT OF TRANSPORTATION
FEDERAL HIGHWAY ADMINISTRATION
APPROVED: *[Signature]*
DIVISION ADMINISTRATOR
2-23-79
DATE

DEPARTMENT OF TRANSPORTATION
STATE OF HAWAII
APPROVED: *Ryokichi Higashimura*
DIR. OF TRANSPORTATION
Feb 2, 1979
DATE