

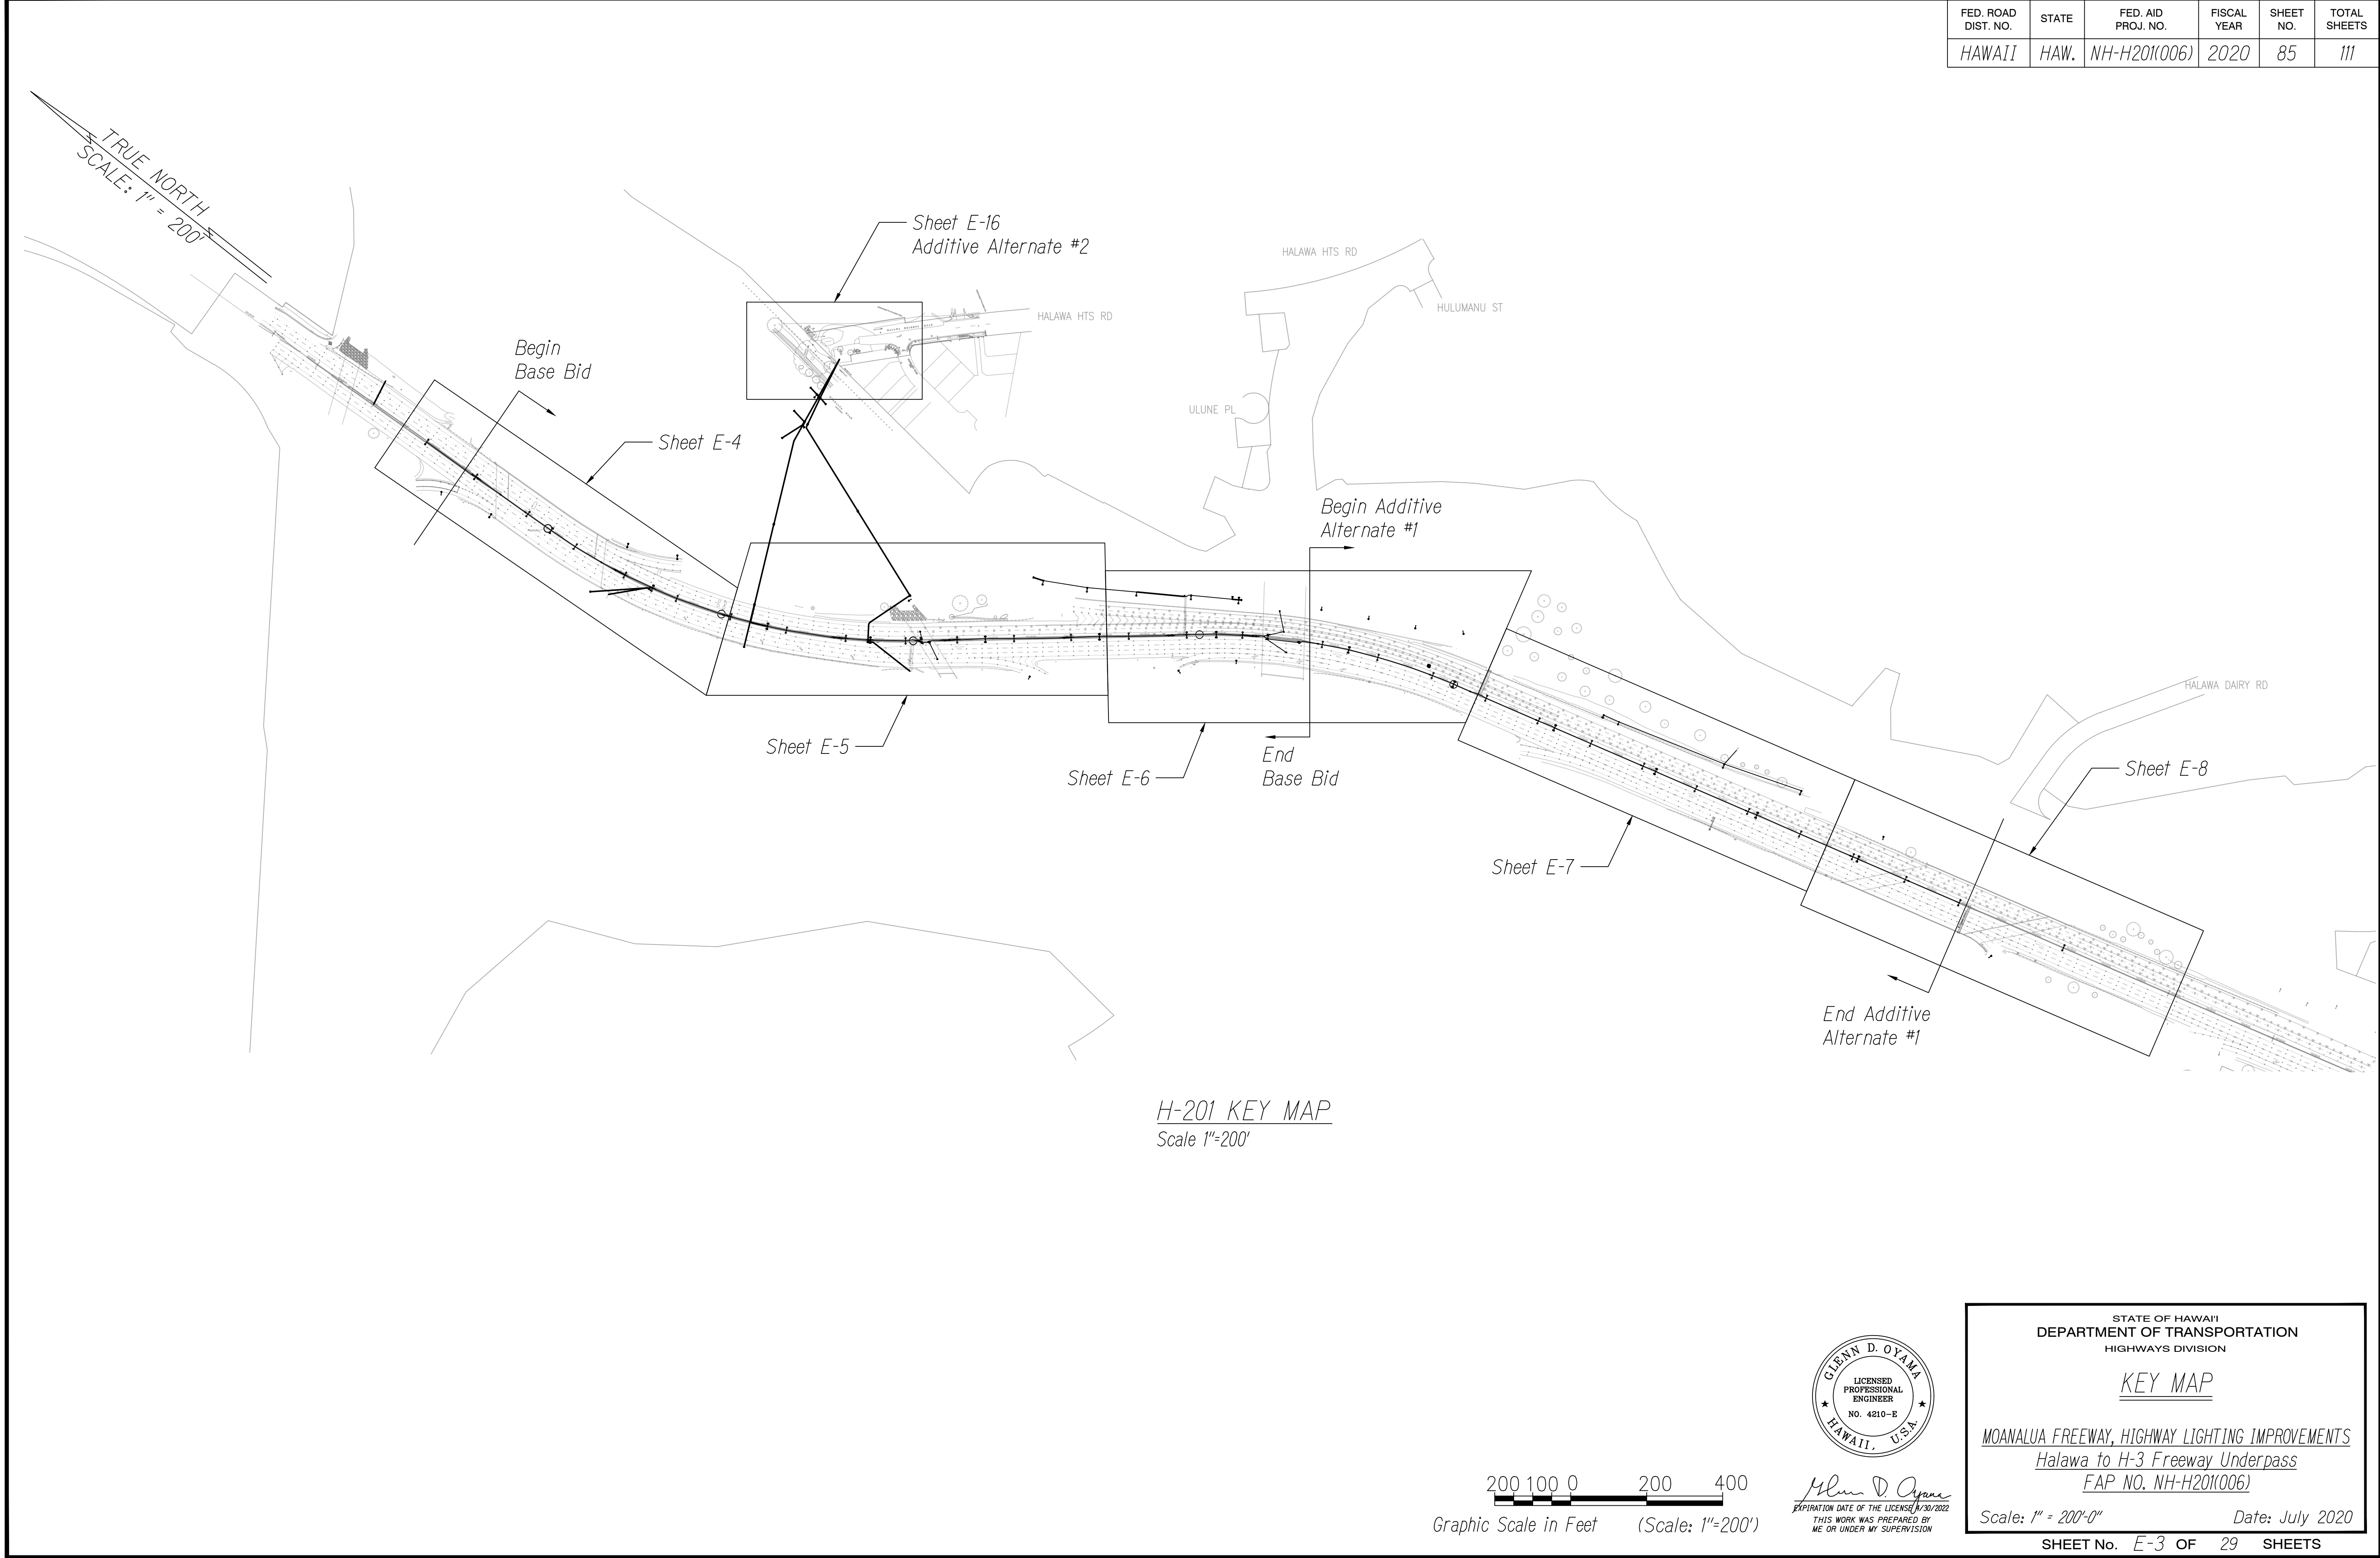


FED. ROAD DIST. NO.	STATE	FED. AID PROJ. NO.	FISCAL YEAR	SHEET NO.	TOTAL SHEETS
HAWAII	HAW.	NH-H201(006)	2020	85	111

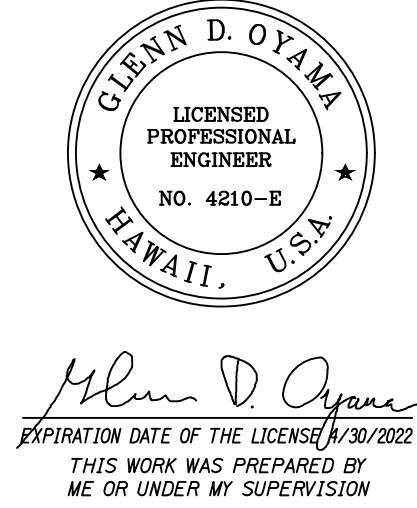

ORIGINAL PLAN	SURVEY PLOTTED BY	DATE
NOTE BOOK	DESIGNED BY	
No.	CHECKED BY	

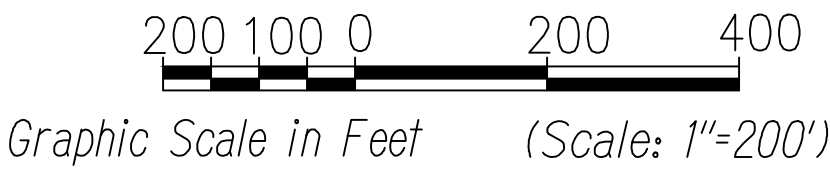

STATE OF HAWAII
DEPARTMENT OF TRANSPORTATION
HIGHWAYS DIVISION

KEY MAP


MOANALUA FREEWAY, HIGHWAY LIGHTING IMPROVEMENTS
Halawa to H-3 Freeway Underpass
FAP NO. NH-H201(006)

Scale: 1" = 200'-0"

Date: July 2020



SHEET No. E-3 OF 29 SHEETS

FED. ROAD DIST. NO.	STATE	FED. AID PROJ. NO.	FISCAL YEAR	SHEET NO.	TOTAL SHEETS
HAWAII	HAW.	NH-H201(006)	2020	86	111

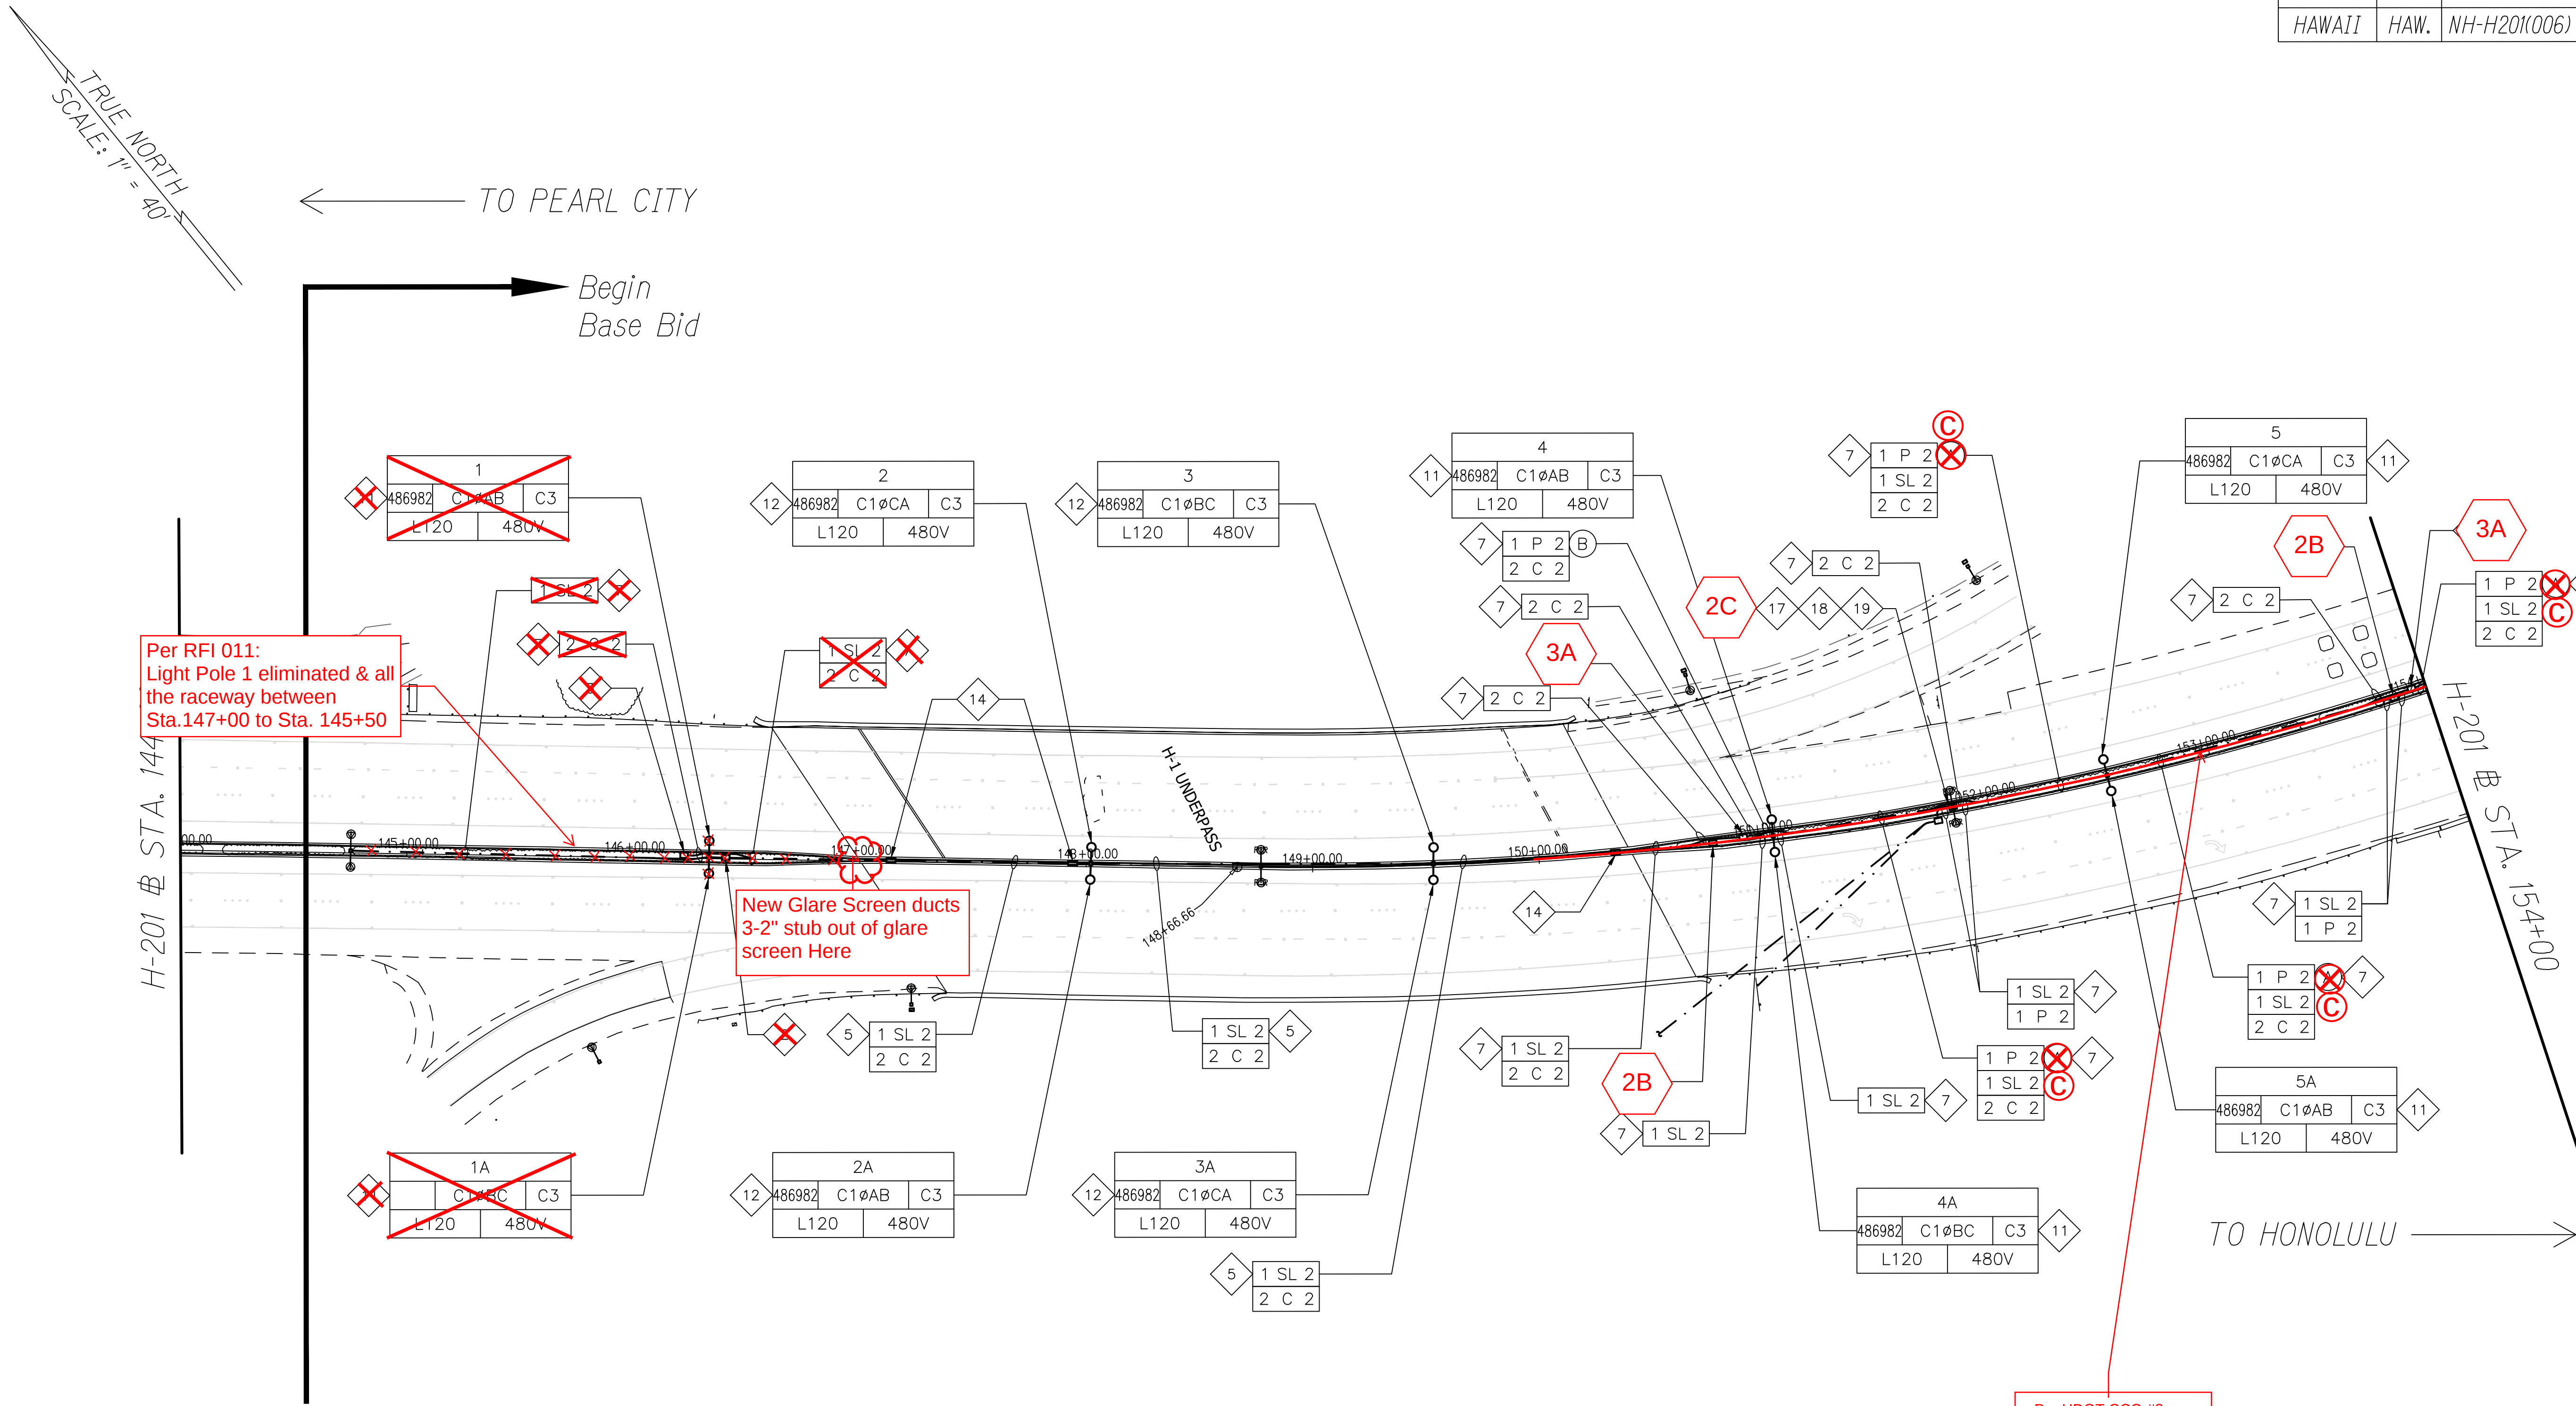

ORIGINAL PLAN	SURVEY PLOTTED BY	DATE
NOTE BOOK	DRAWN BY	
No.	DESIGNED BY	
	QUANTITIES BY	
	CHECKED BY	

H-201 LIGHTING PLAN-1
Scale 1"=40'-0"

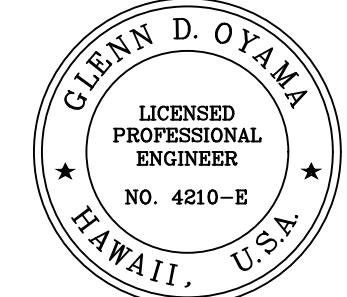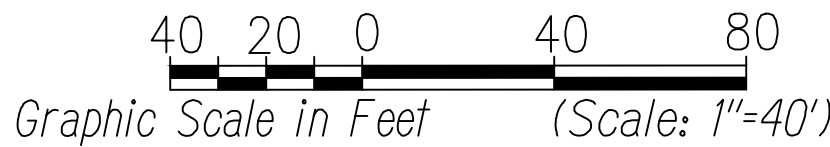

Glenn D. Oyama
EXPIRATION DATE OF THE LICENSE 11/30/2022
THIS WORK WAS PREPARED BY ME OR UNDER MY SUPERVISION


STATE OF HAWAII
DEPARTMENT OF TRANSPORTATION
HIGHWAYS DIVISION
H-201 LIGHTING PLAN
STA. 144+00 TO 154+00
MOANALUA FREEWAY, HIGHWAY LIGHTING IMPROVEMENTS
Halawa to H-3 Freeway Underpass
FAP NO. NH-H201(006)
Scale: 1" = 40'-0" Date: July 2020
SHEET No. E-4 OF 29 SHEETS

"AS-BUILT"

FED. ROAD DIST. NO.	STATE	FED. AID PROJ. NO.	FISCAL YEAR	SHEET NO.	TOTAL SHEETS
HAWAII	HAW.	NH-H201(006)	2020	88	111


RFI 032:
FDR "D" Splice Into Ckt D at existng pullbox and new duct-line rerouted from exst pullbox and dead ends @ LP G4A

RFI 032:
FDR "D" Splice Into Ckt D at existng pullbox and new duct-line rerouted from exst pullbox and dead ends @ LP G5A

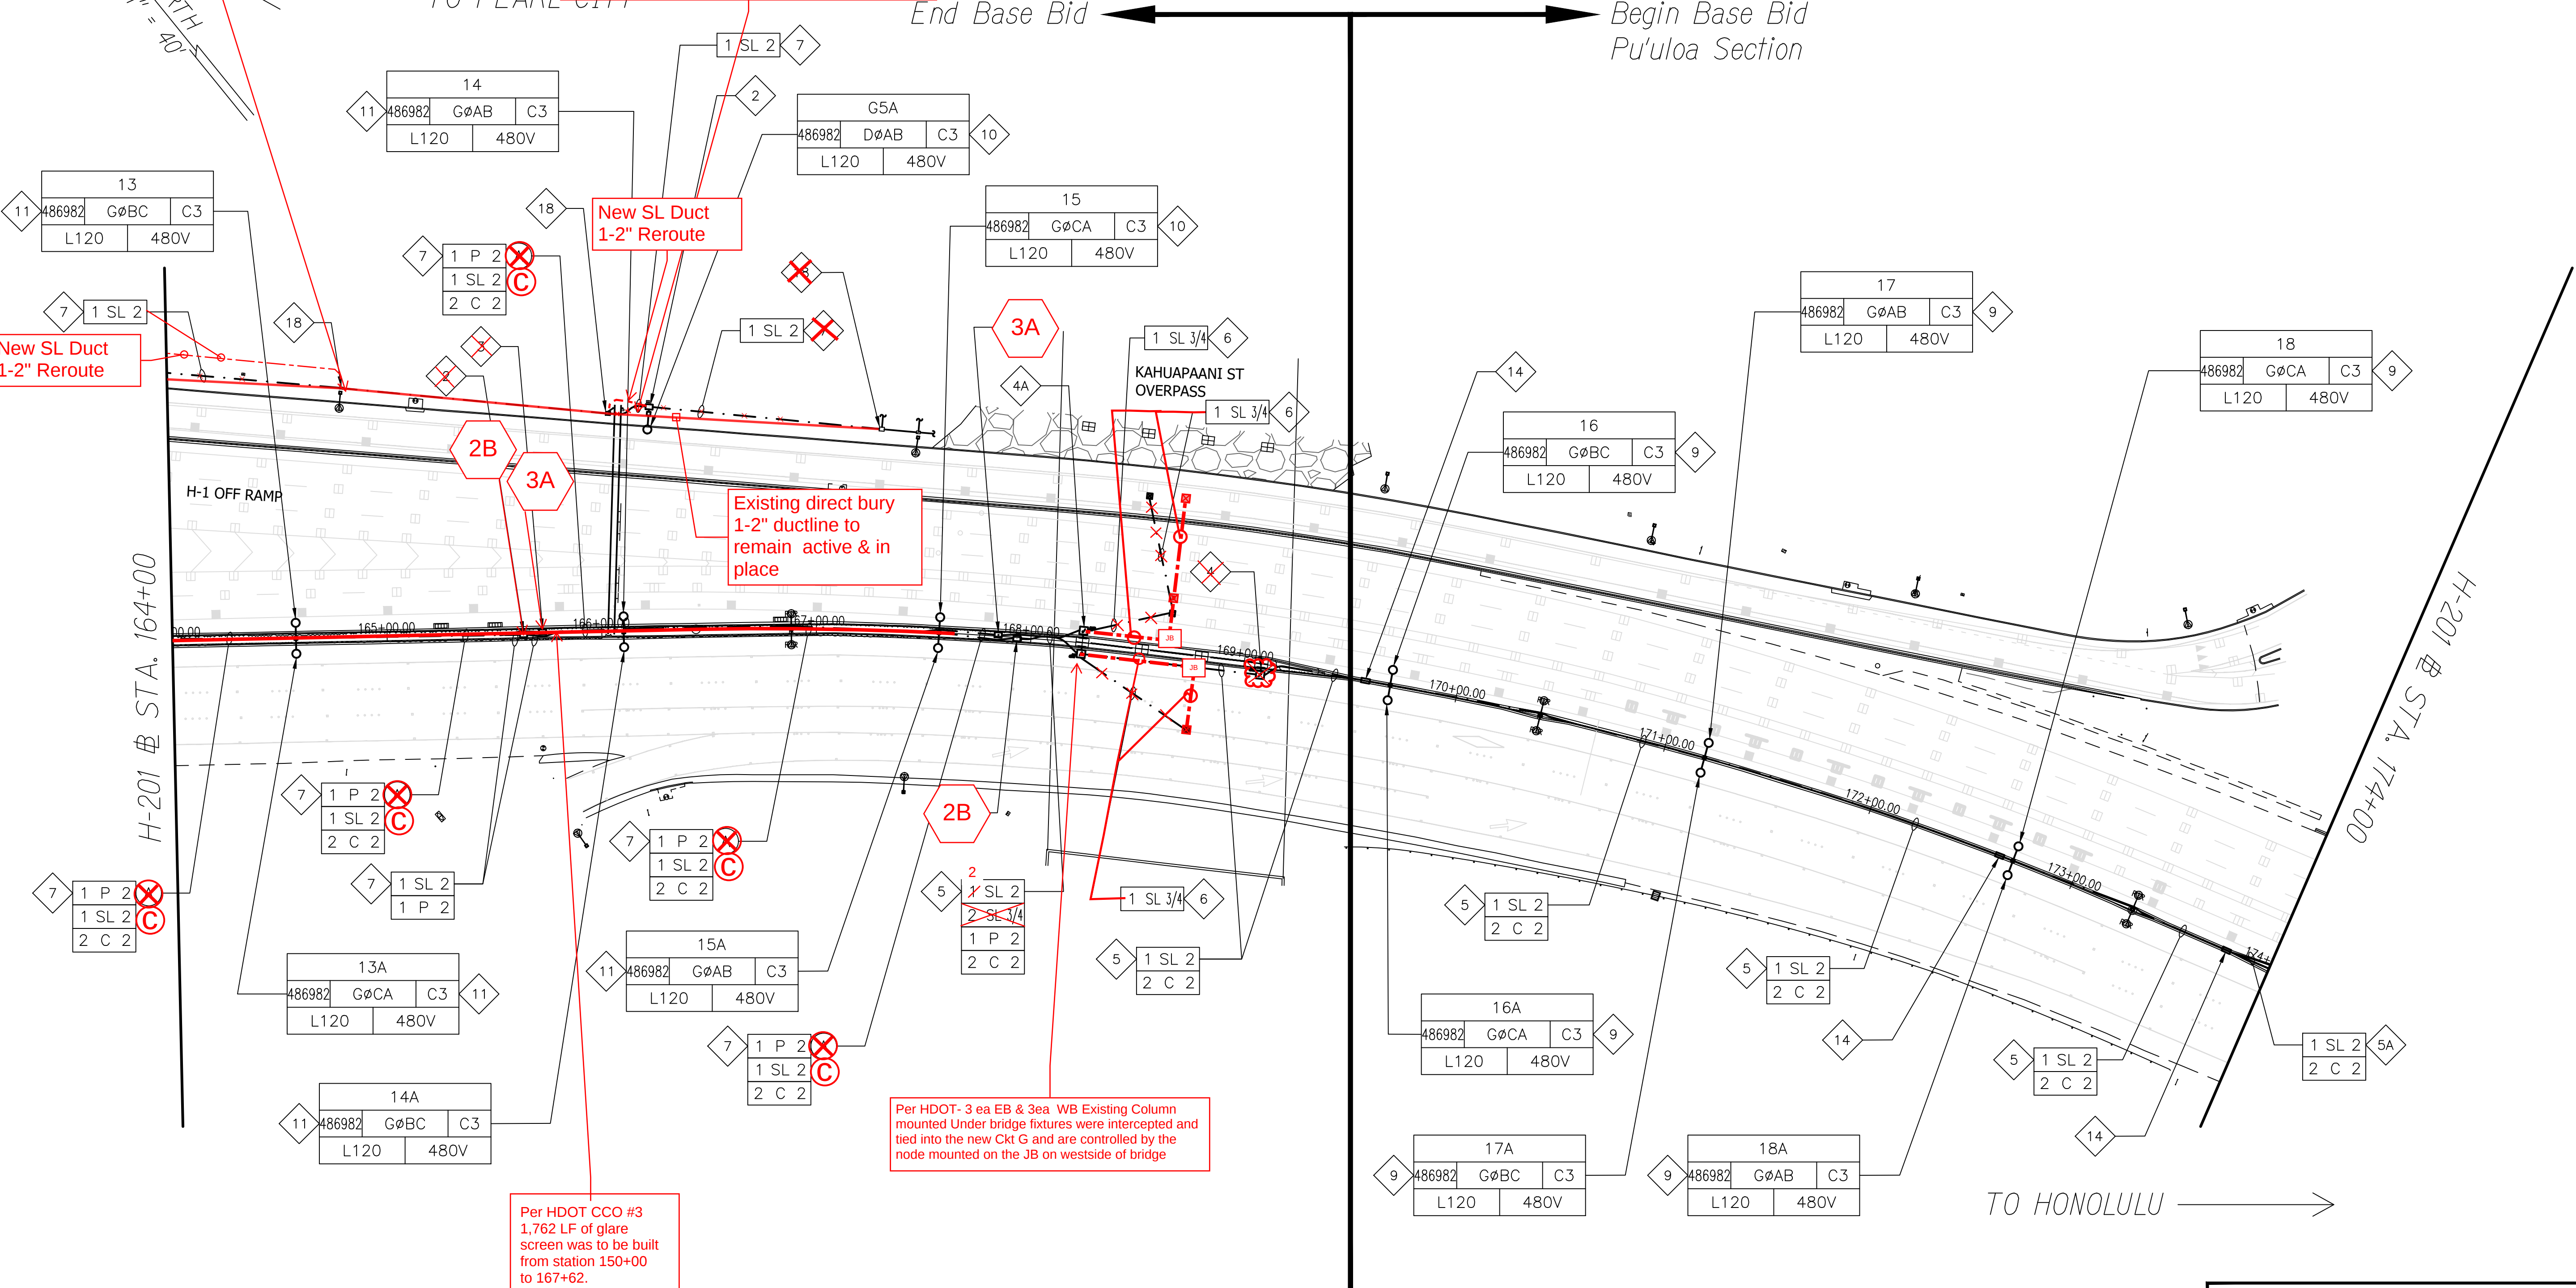

ORIGINAL PLAN	SURVEY PLOTTED BY	DATE
	DESIGNED BY	
	QUANTITIES BY	
	CHECKED BY	
NOTE BOOK		
No.		

H-201 LIGHTING PLAN-3
Scale 1"=40'-0"


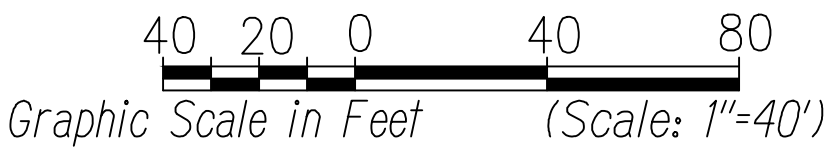


Glenn D. Oyama
EXPIRATION DATE OF THE LICENSE 11/30/2022
THIS WORK WAS PREPARED BY ME OR UNDER MY SUPERVISION

STATE OF HAWAII
DEPARTMENT OF TRANSPORTATION
HIGHWAYS DIVISION
H-201 LIGHTING PLAN
STA. 164+00 TO 174+00
MOANALUA FREEWAY, HIGHWAY LIGHTING IMPROVEMENTS
Halawa to H-3 Freeway Underpass
FAP NO. NH-H201(006)
Scale: 1" = 40'-0" Date: July 2020
SHEET No. E-6 OF 29 SHEETS


"AS-BUILT"

FED. ROAD DIST. NO.	STATE	FED. AID PROJ. NO.	FISCAL YEAR	SHEET NO.	TOTAL SHEETS
HAWAII	HAW.	NH-H201(006)	2020	89	111

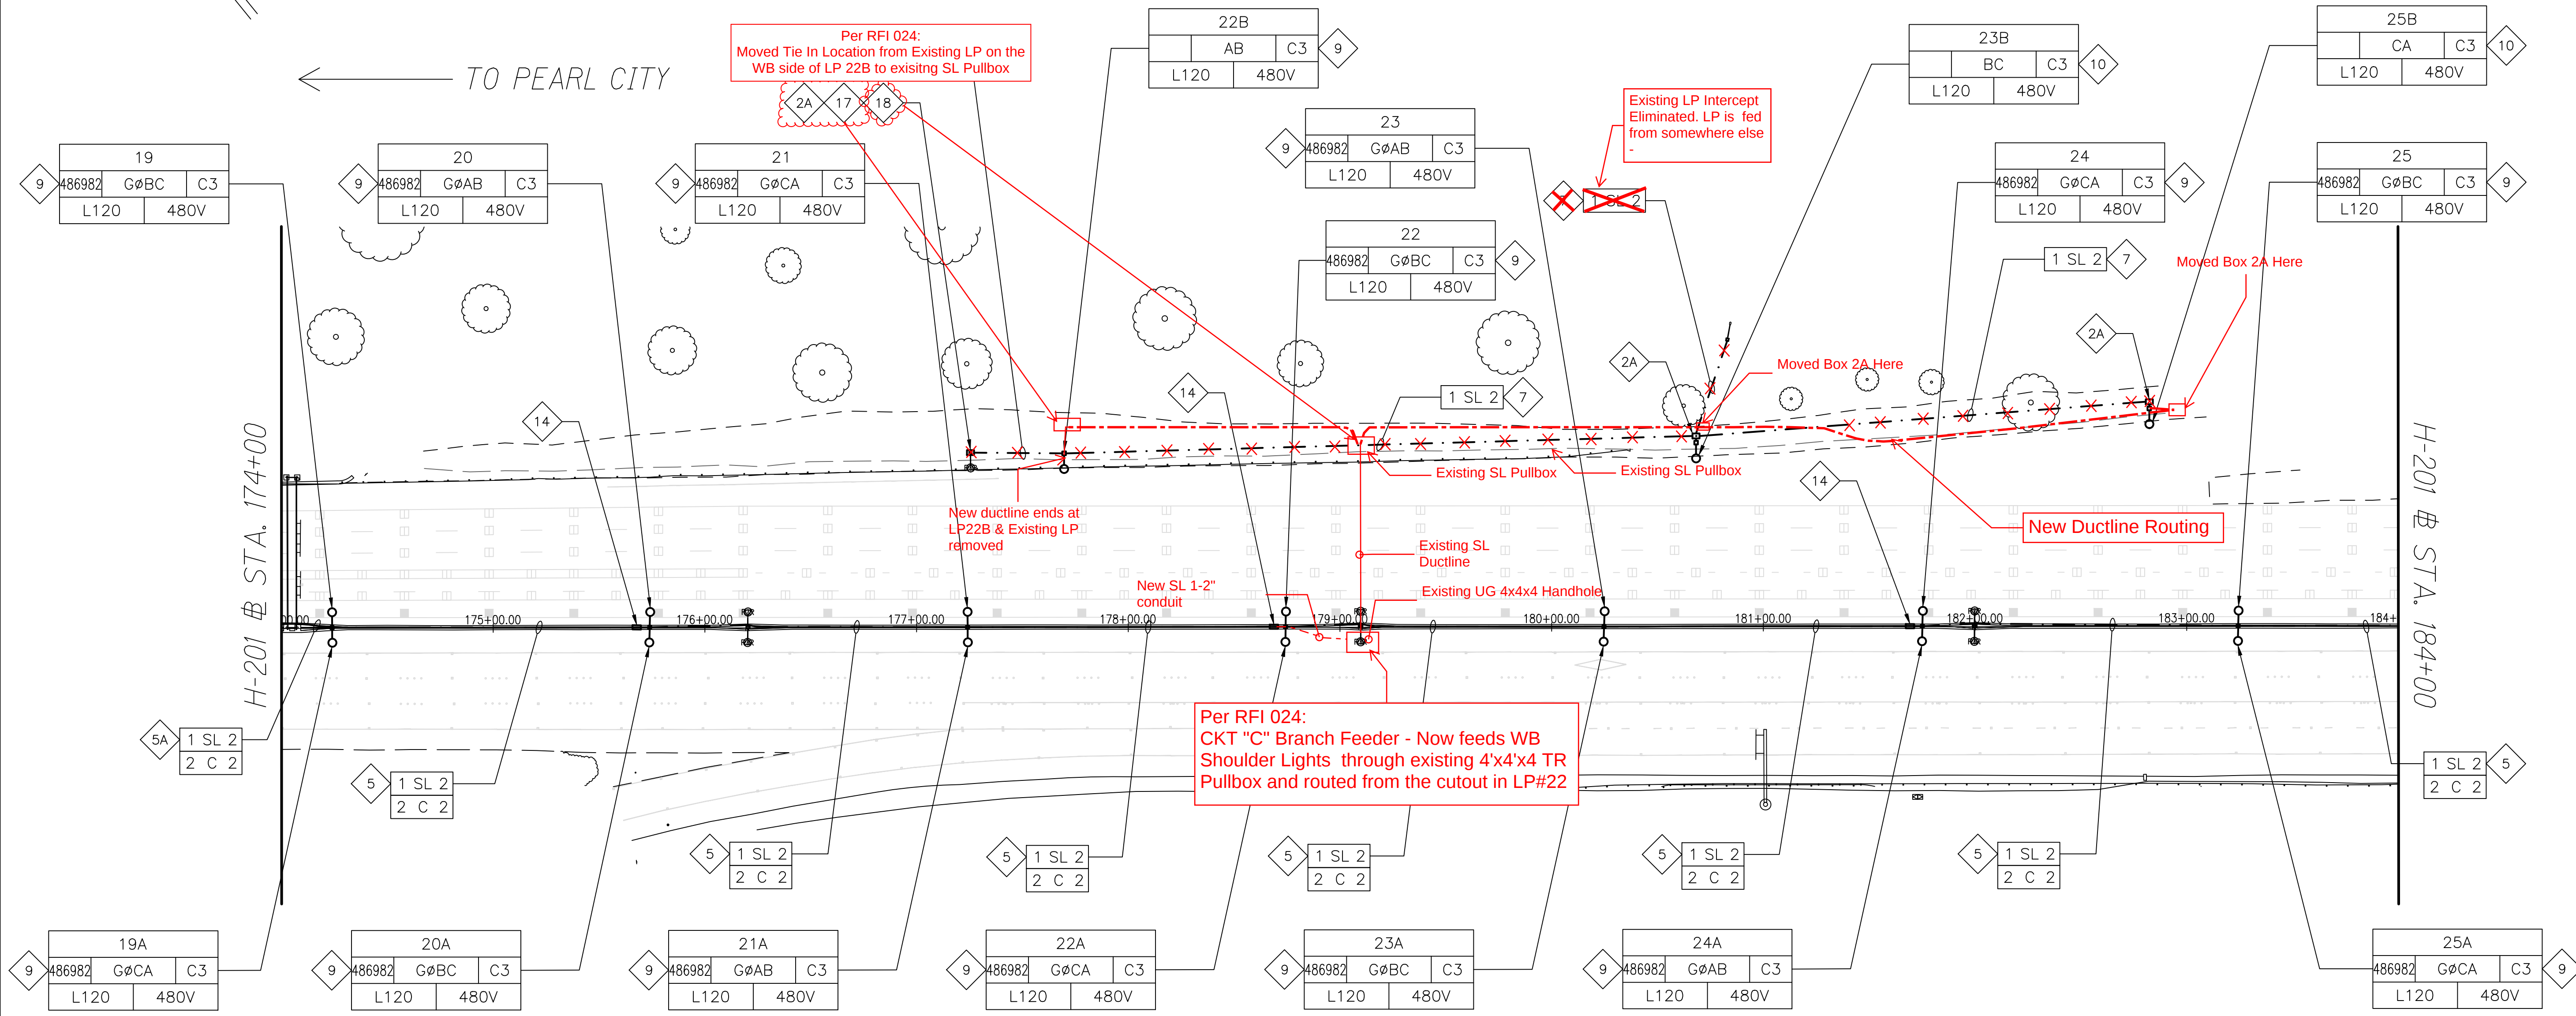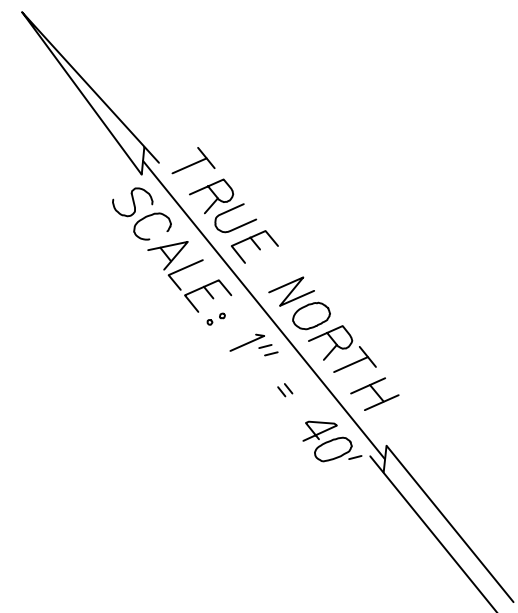

ORIGINAL PLAN	SURVEY PLOTTED BY _____		DATE _____
	DRAWN BY _____		_____
	TRACED BY _____		_____
	DESIGNED BY _____		_____
NOTE BOOK	QUANTITIES BY _____		_____
	CHECKED BY _____		_____
	No. _____		_____

H-201 LIGHTING PLAN-4 (ADDITIVE ALT. #1)
Scale 1"=40'-0"

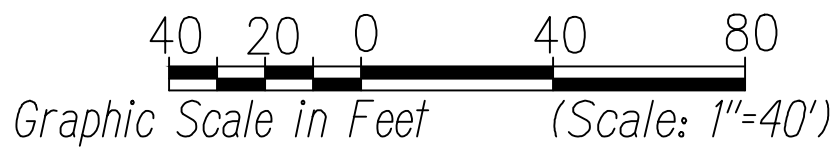

Glenn D. Oyama
EXPIRATION DATE OF THE LICENSE 11/30/2022
THIS WORK WAS PREPARED BY ME OR UNDER MY SUPERVISION


STATE OF HAWAII
DEPARTMENT OF TRANSPORTATION
HIGHWAYS DIVISION
H-201 ADD. ALT. #1 LIGHTING
PLAN STA. 174+00 TO 184+00
MOANALUA FREEWAY, HIGHWAY LIGHTING IMPROVEMENTS
Halawa to H-3 Freeway Underpass
FAP NO. NH-H201(006)
Scale: 1" = 40'-0" Date: July 2020
SHEET No. E-7 OF 29 SHEETS

"AS-BUILT"

FED. ROAD DIST. NO.	STATE	FED. AID PROJ. NO.	FISCAL YEAR	SHEET NO.	TOTAL SHEETS
HAWAII	HAW.	NH-H201(006)	2020	90	111


TRUE NORTH
SCALE: 1" = 40'

← TO PEARL CITY

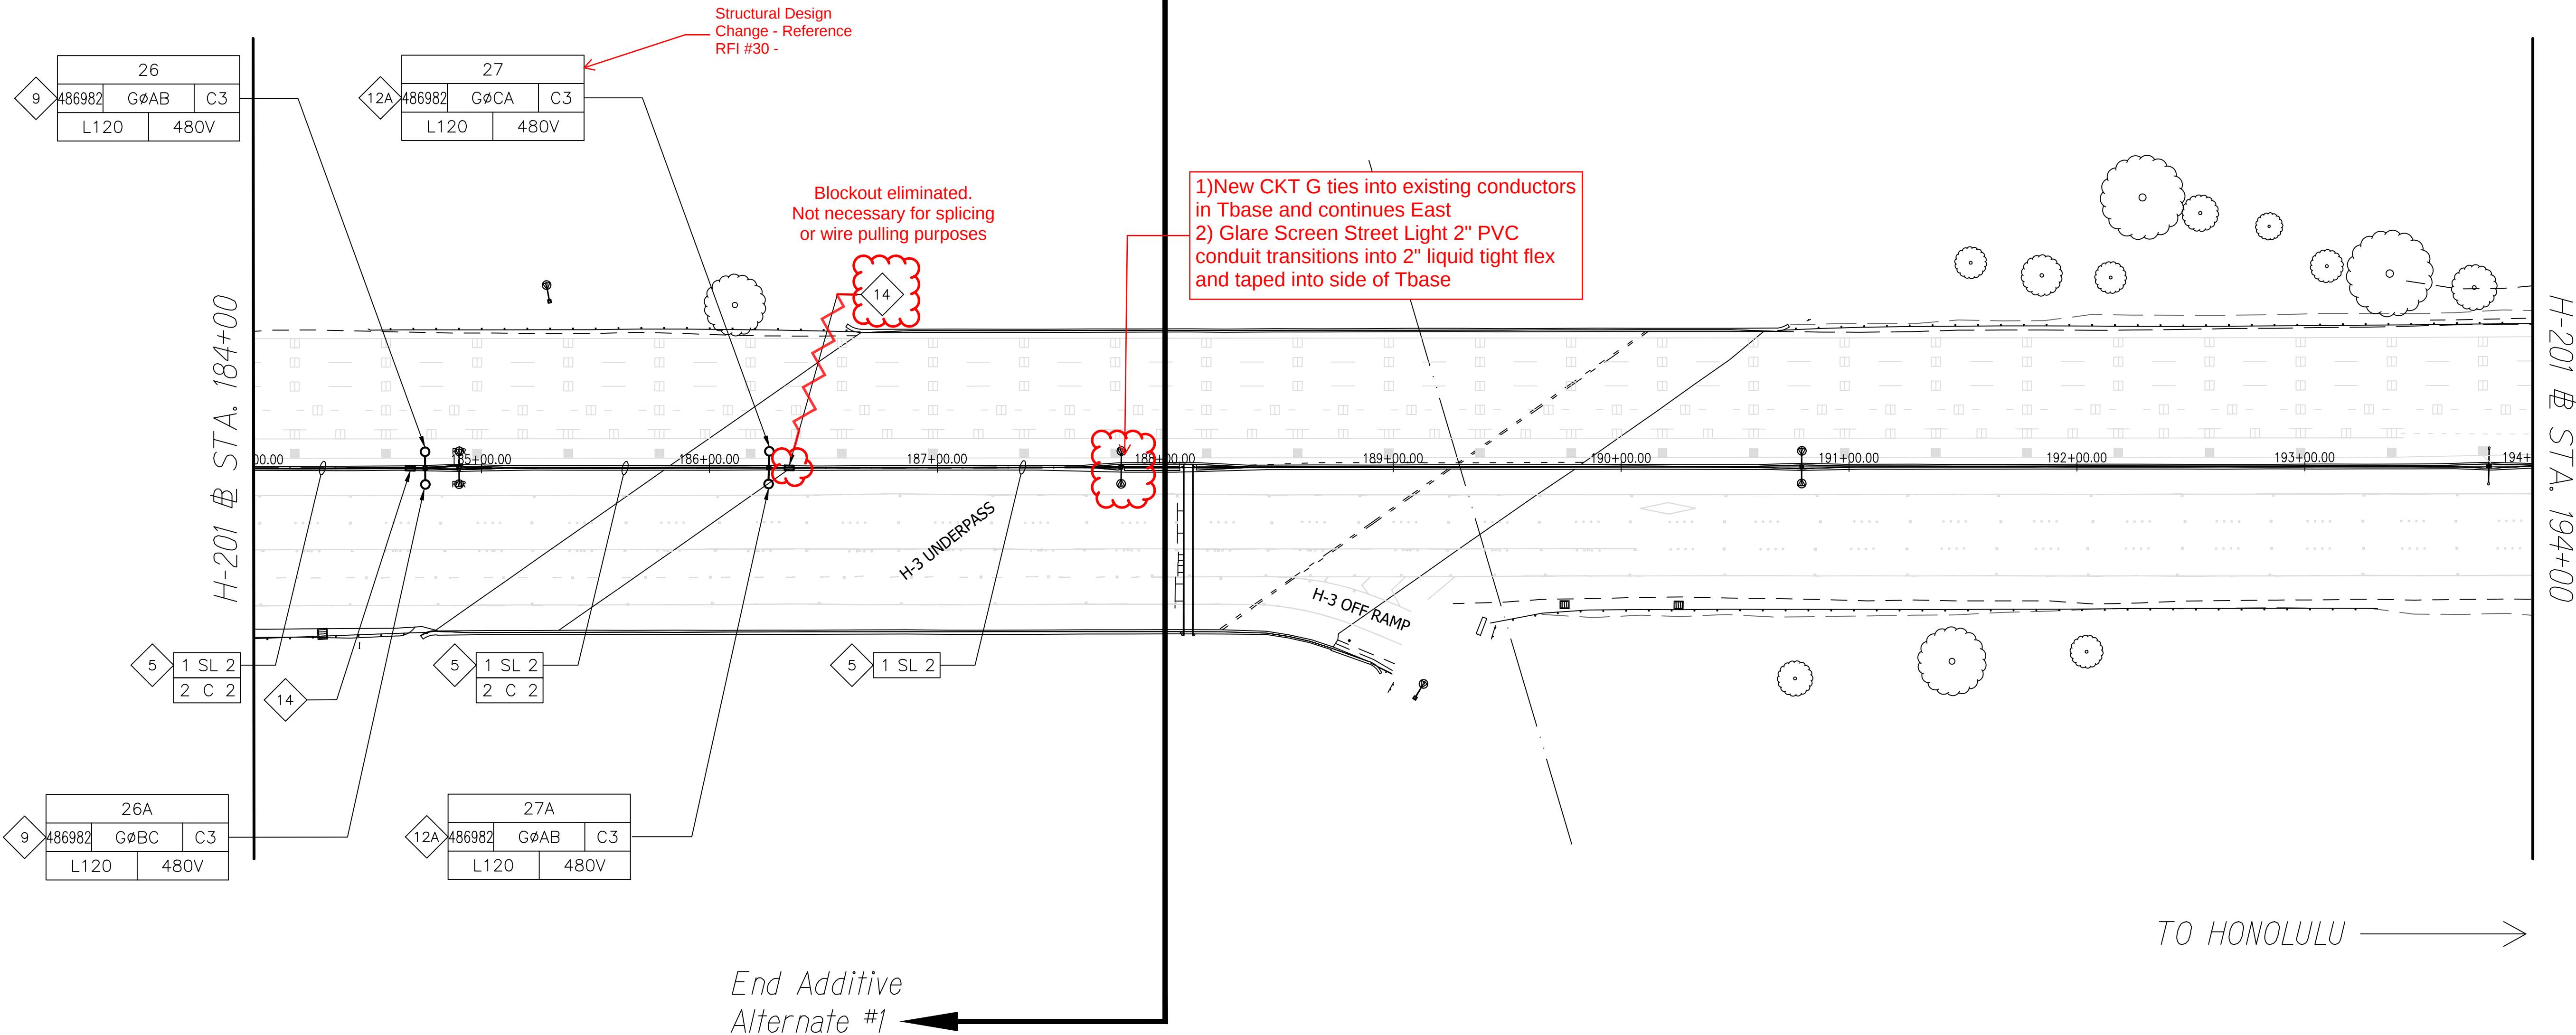

ORIGINAL PLAN	SURVEY PLOTTED BY	DATE
	DRAWN BY	
	DESIGNED BY	
	QUANTITIES BY	
NOTE BOOK	CHECKED BY	
	No.	

H-201 LIGHTING PLAN-5 (ADDITIVE ALT. #1)
Scale 1"=40'-0"

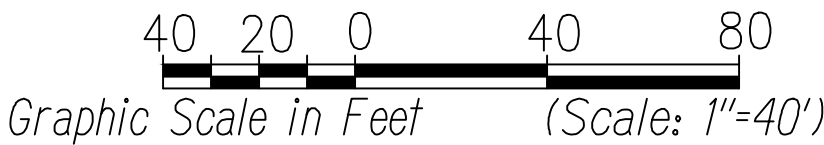

Glenn D. Oyama
EXPIRATION DATE OF THE LICENSE 11/30/2022
THIS WORK WAS PREPARED BY ME OR UNDER MY SUPERVISION

STATE OF HAWAII
DEPARTMENT OF TRANSPORTATION
HIGHWAYS DIVISION
H-201 ADD. ALT. #1 LIGHTING
PLAN STA. 184+00 TO 194+00
MOANALUA FREEWAY, HIGHWAY LIGHTING IMPROVEMENTS
Halawa to H-3 Freeway Underpass
FAP NO. NH-H201(006)
Scale: 1" = 40'-0" Date: July 2020
SHEET No. E-8 OF 29 SHEETS

"AS-BUILT"