



FED. ROAD DIST. NO.	STATE	FED. AID PROJ. NO.	FISCAL YEAR	SHEET NO.	TOTAL SHEETS
HAWAII	HAW.	NH-H201(006)	2020	9698	111

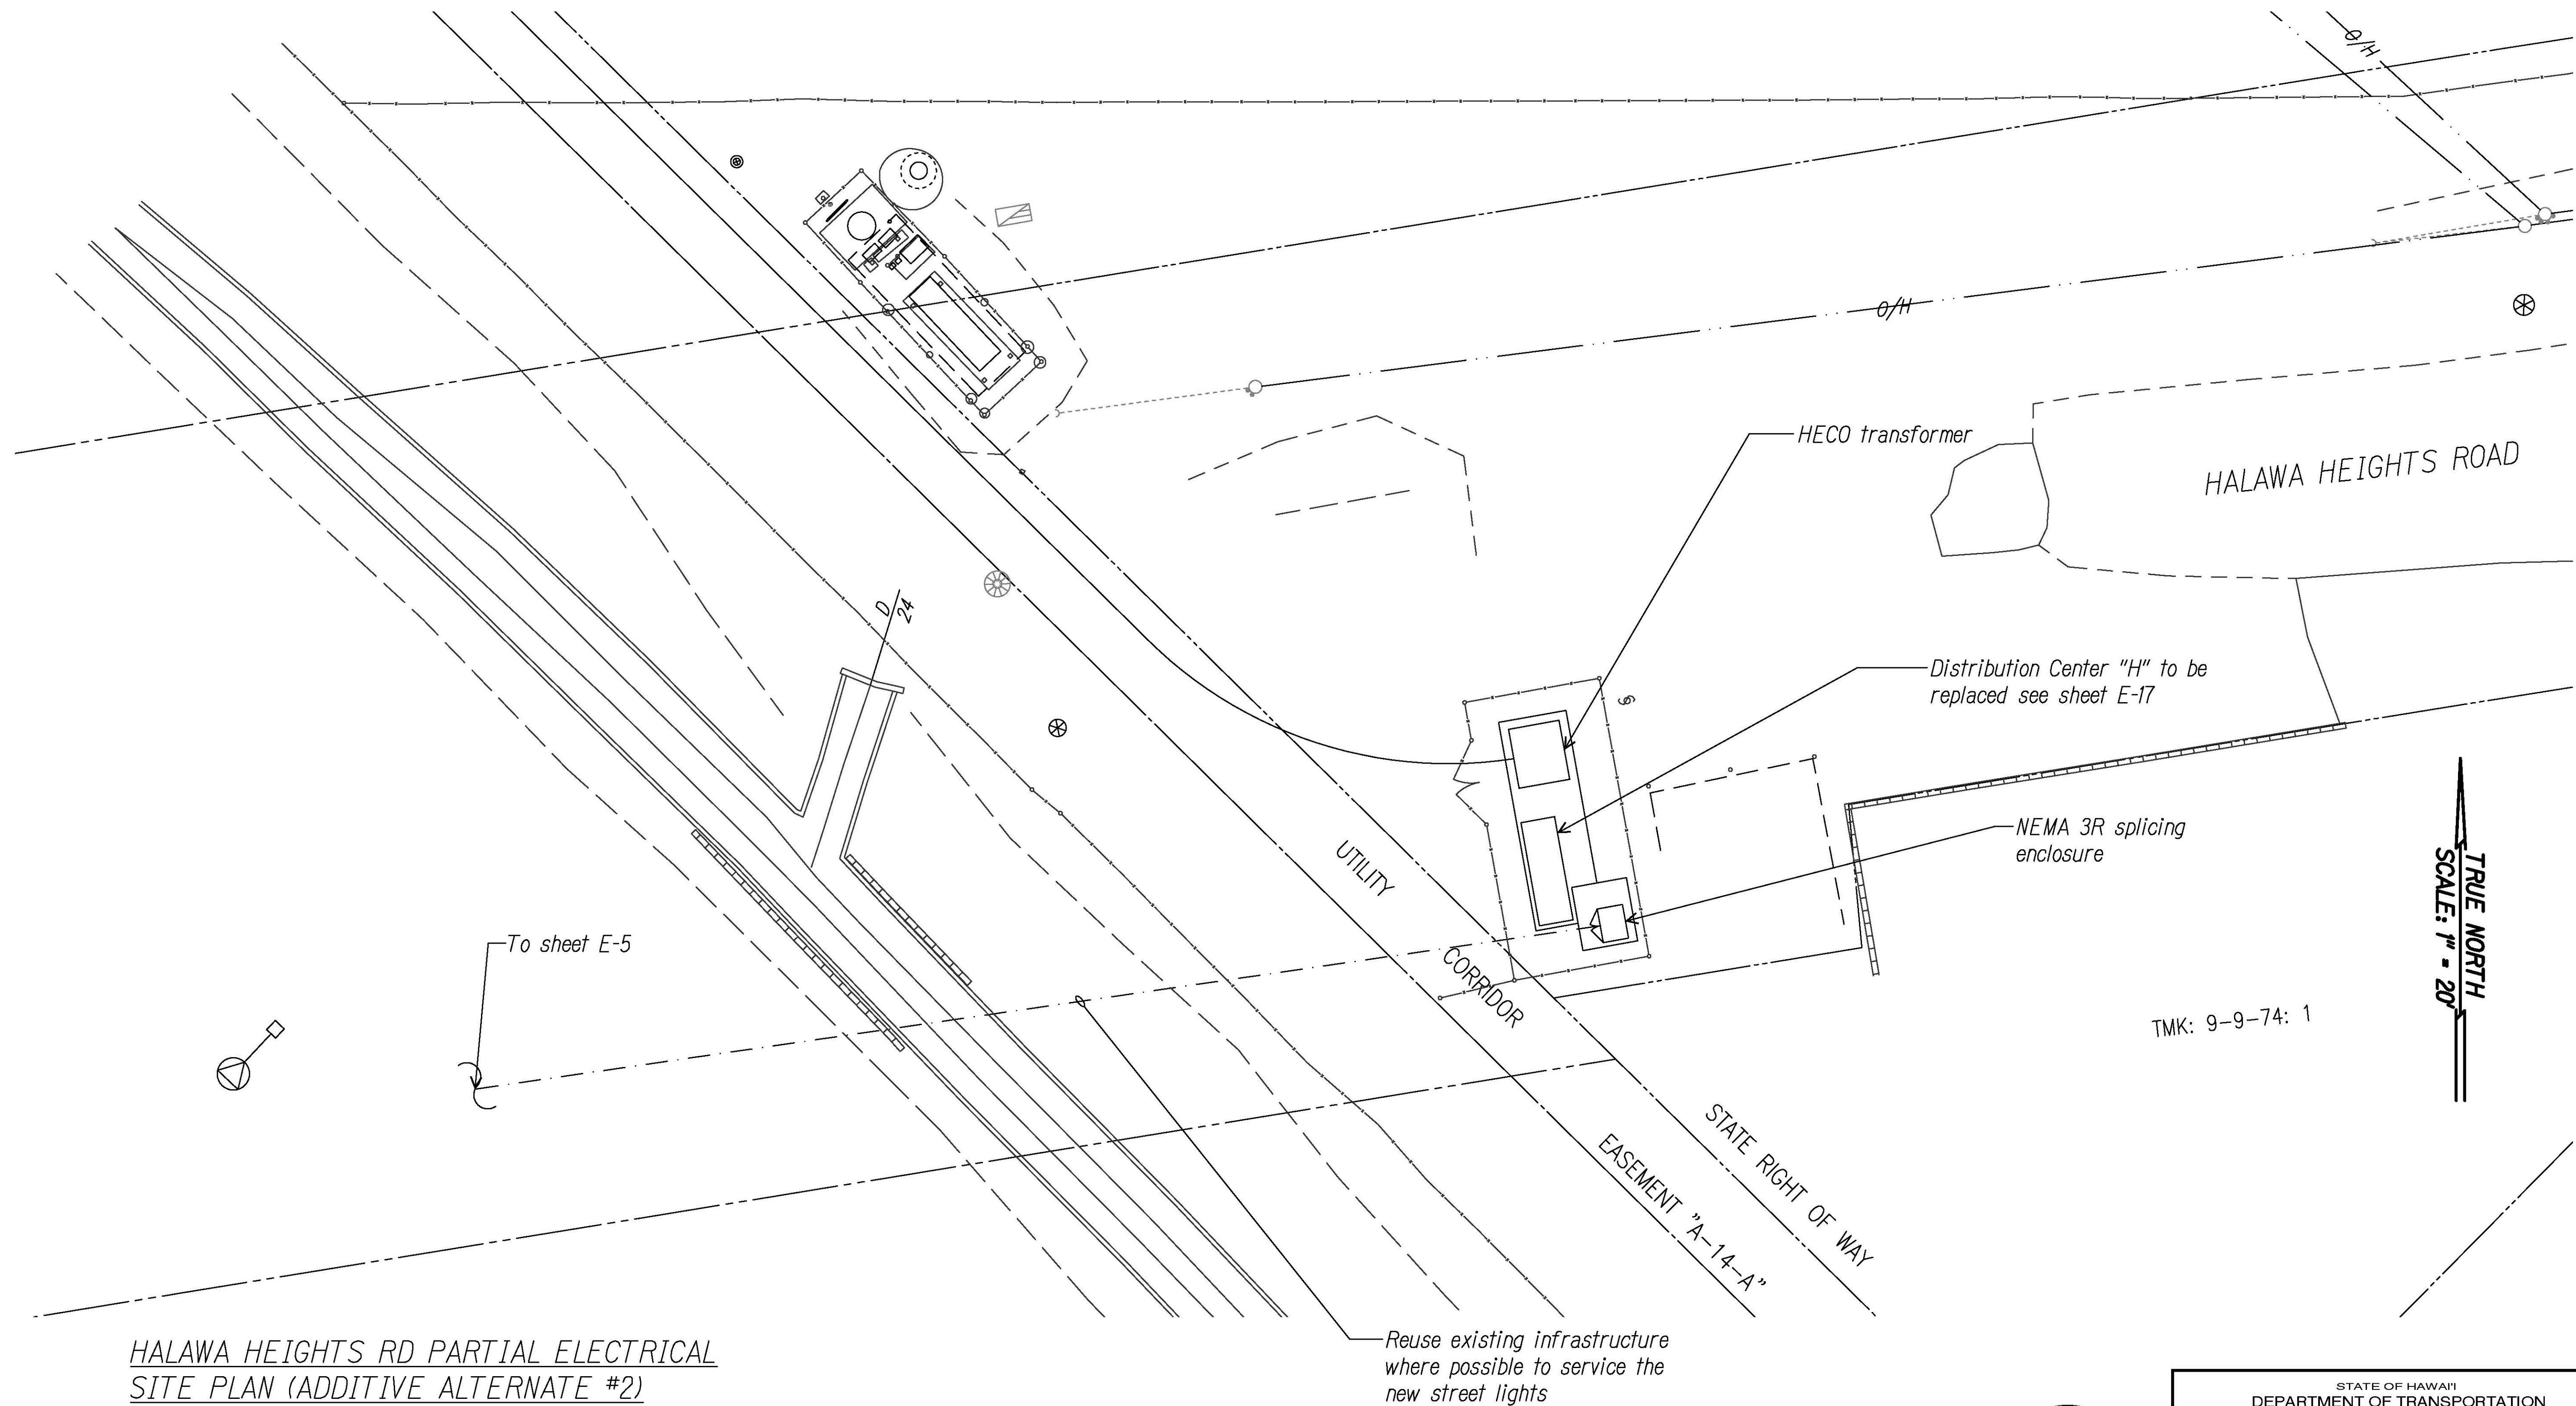

HALAWA HEIGHTS RD PARTIAL ELECTRICAL  
SITE PLAN (ADDITIVE ALTERNATE #2)  
Scale 1"=10'-0"

ORIGINAL PLAN	SURVEY PLOTTED BY	DATE
NOTE BOOK	DESIGNED BY	
No.	CHECKED BY	

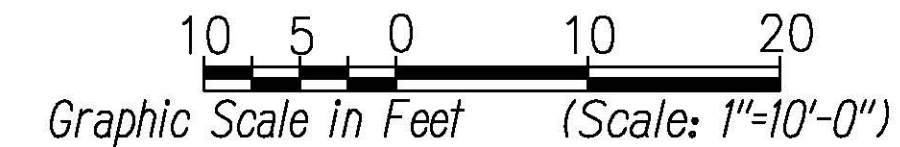


GLENN D. OTAKA  
LICENSED PROFESSIONAL ENGINEER  
NO. 4210-E  
HAWAII, U.S.A.

*Glenn D. Otaka*  
EXPIRATION DATE OF THE LICENSE: 1/30/2022  
THIS WORK WAS PREPARED BY  
ME OR UNDER MY SUPERVISION



STATE OF HAWAII  
DEPARTMENT OF TRANSPORTATION  
HIGHWAYS DIVISION  
**HALAWA HEIGHTS RD  
PARTIAL ELECTRICAL SITE PLAN**  
MOANALUA FREEWAY, HIGHWAY LIGHTING IMPROVEMENTS  
Halawa to H-3 Freeway Underpass  
FAP NO. NH-H201(006)  
Scale: 1" = 10'-0" Date: July 2020  
SHEET No. E-16 OF 29 SHEETS



FED. ROAD DIST. NO.	STATE	FED. AID PROJ. NO.	FISCAL YEAR	SHEET NO.	TOTAL SHEETS
HAWAII	HAW.	NH-H201(006)	2020	99	111

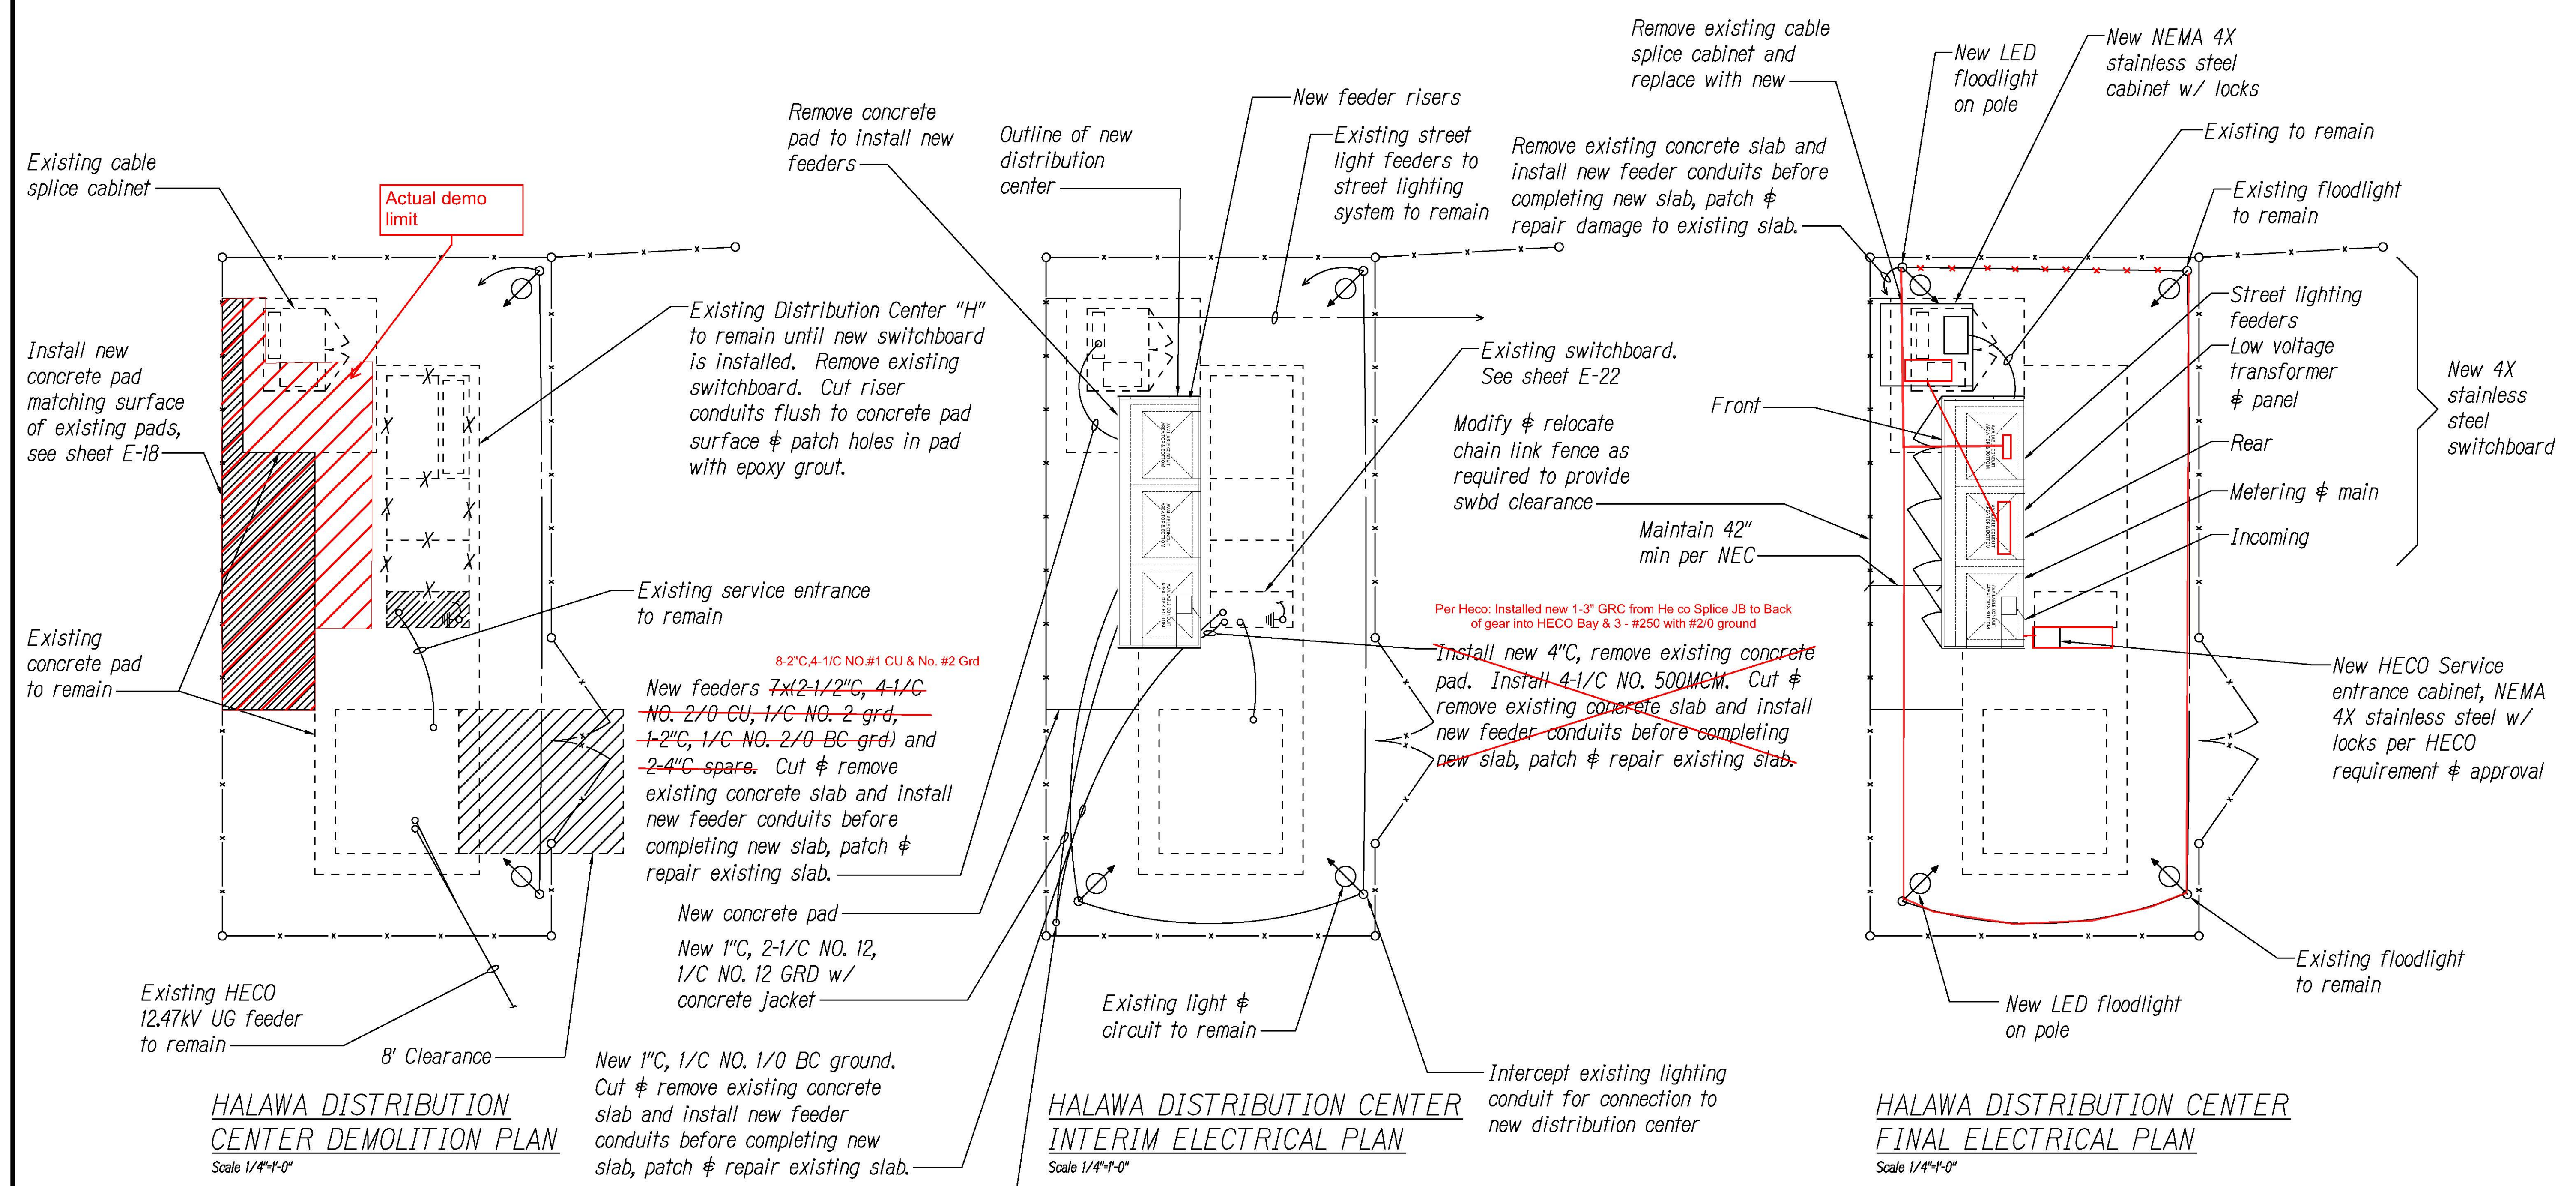

DATE	_____
SURVEY PLOTTED BY	_____
DESIGNED BY	_____
QUANTITIES BY	_____
CHECKED BY	_____
ORIGINAL PLAN	_____
NOTE BOOK	_____
No.	_____

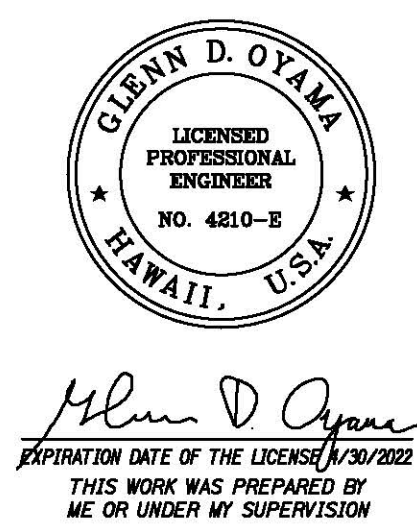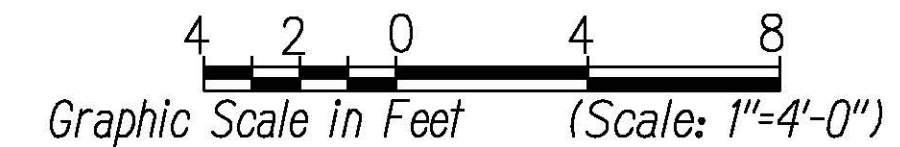


STATE OF HAWAII  
DEPARTMENT OF TRANSPORTATION  
HIGHWAYS DIVISION  
**HALAWA DISTRIBUTION CENTER**  
**SITE PLANS**  
MOANALUA FREEWAY, HIGHWAY LIGHTING IMPROVEMENTS  
Halawa to H-3 Freeway Underpass  
FAP NO. NH-H201(006)  
Scale: 1" = 4'-0" Date: July 2020  
SHEET No. E-17 OF 29 SHEETS

"AS-BUILT"




FED. ROAD DIST. NO.	STATE	FED. AID PROJ. NO.	FISCAL YEAR	SHEET NO.	TOTAL SHEETS
HAWAII	HAW.	NH-H201(006)	2020	100	111

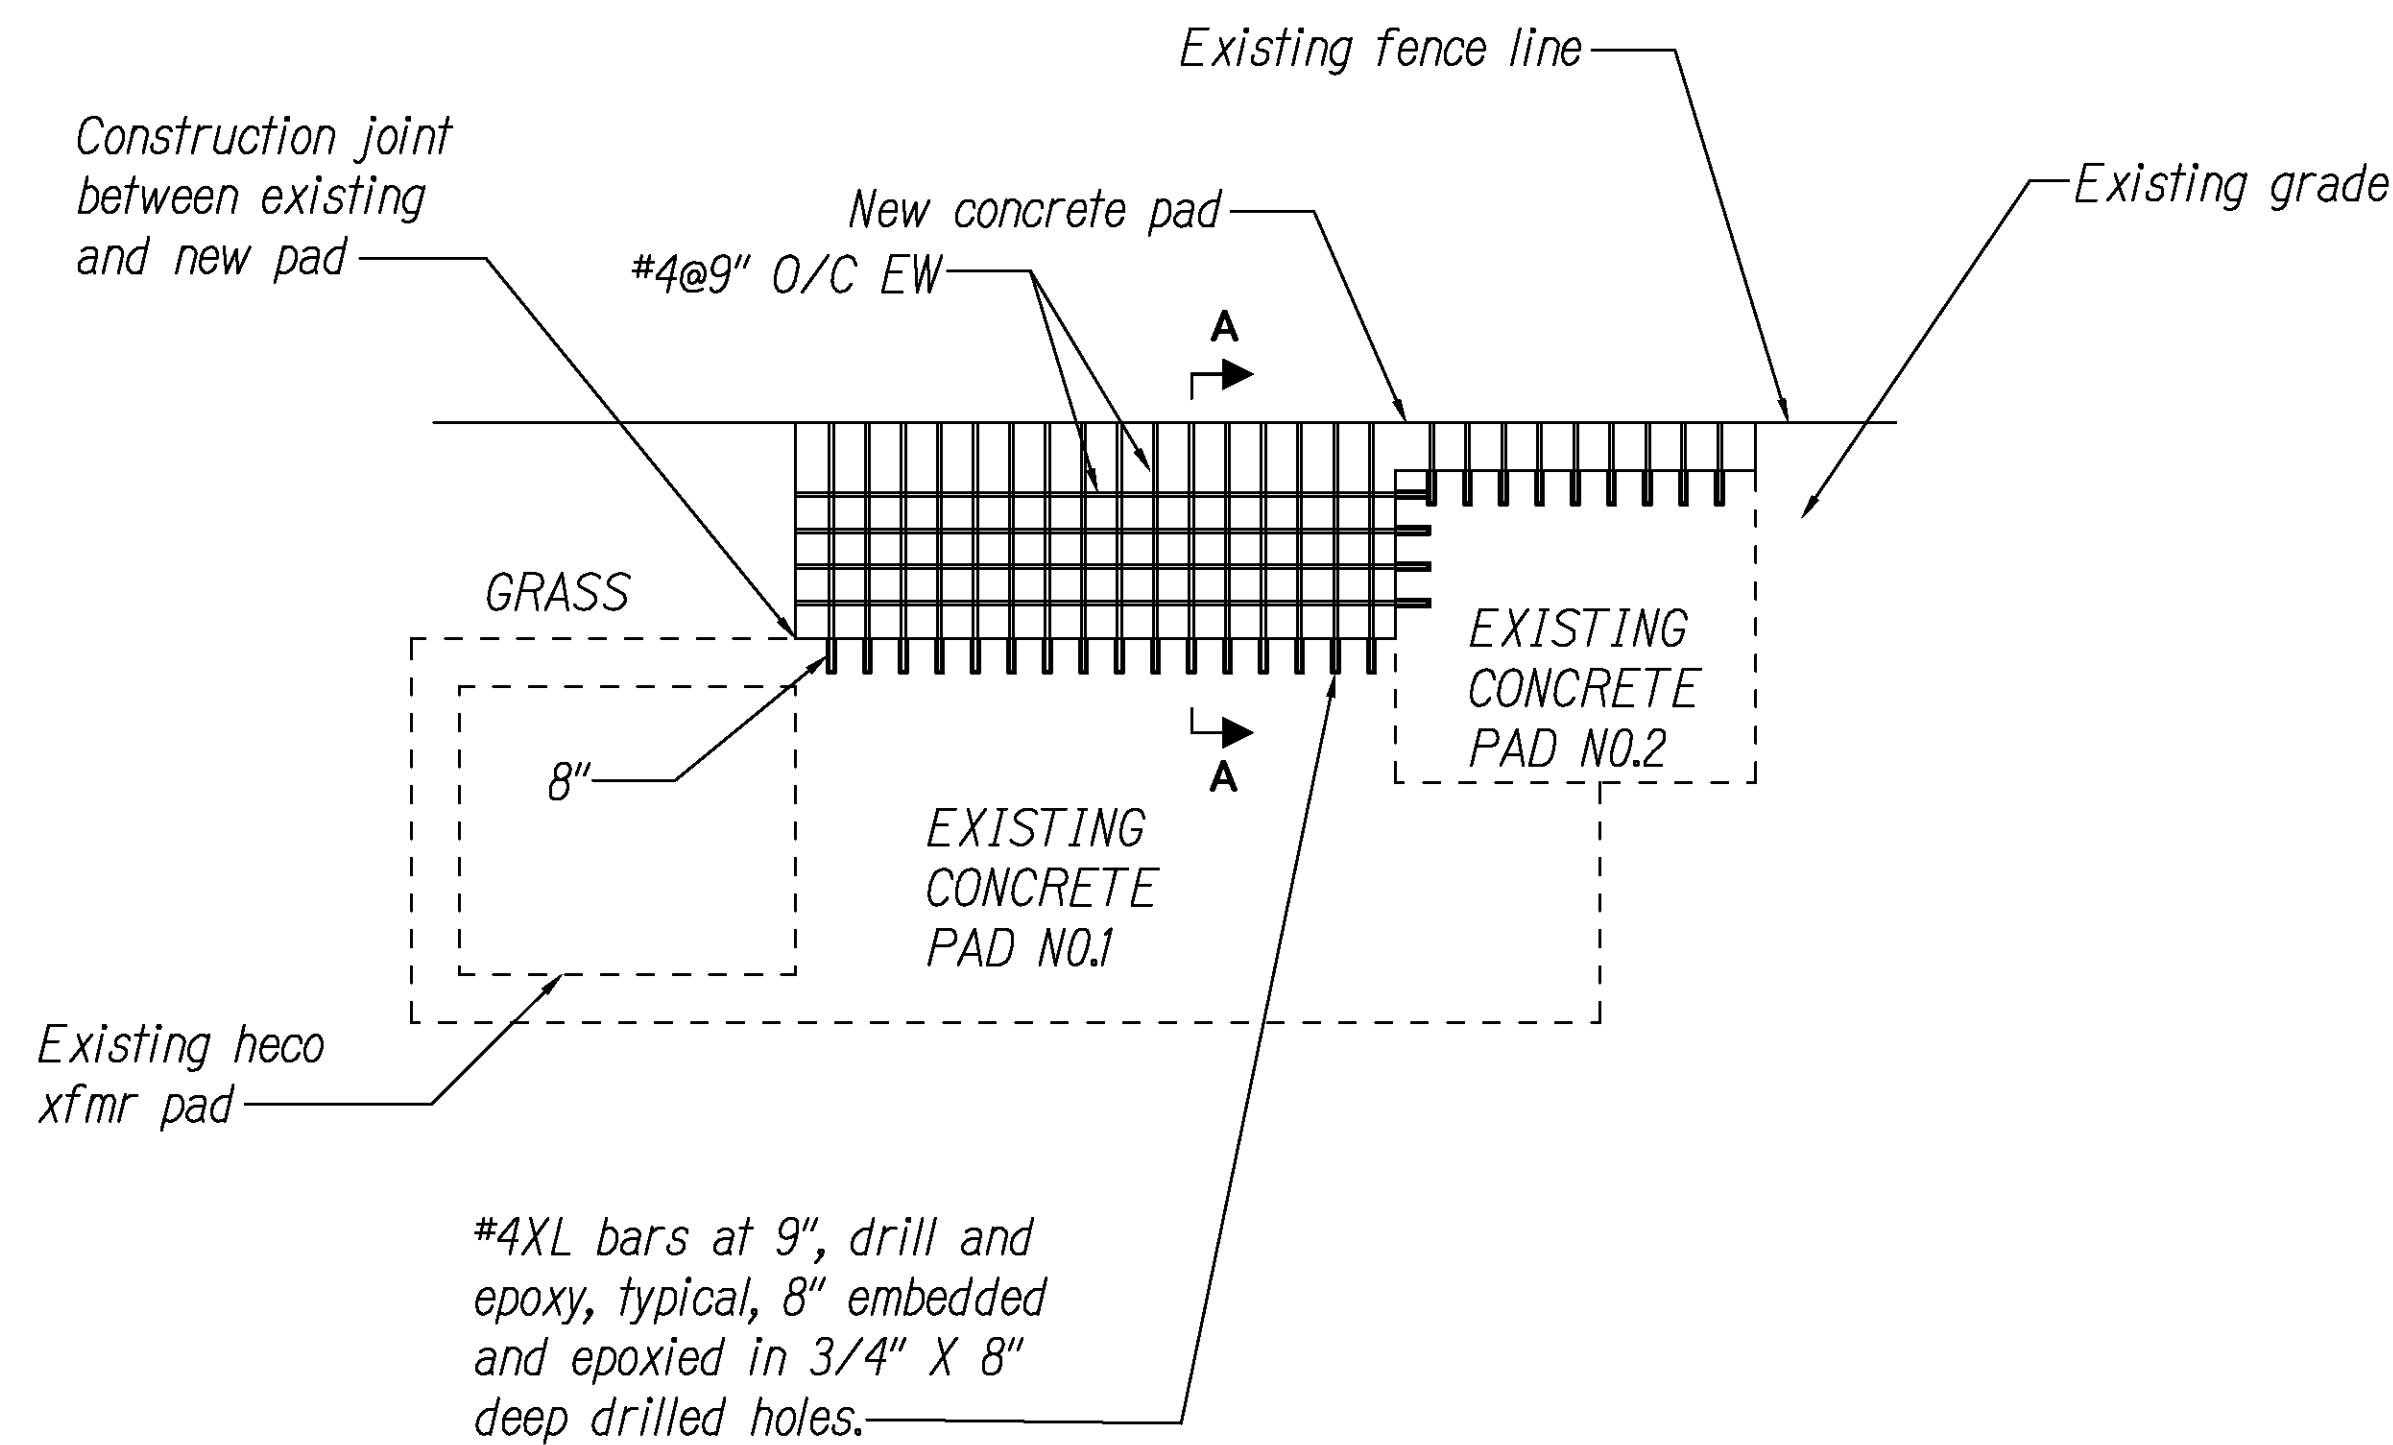


HALAWA DISTRIBUTION CENTER  
CONCRETE PAD PLAN DETAIL  
Scale 1/4"=1'-0"

NOTES:


1. Verify requirements with HECO.

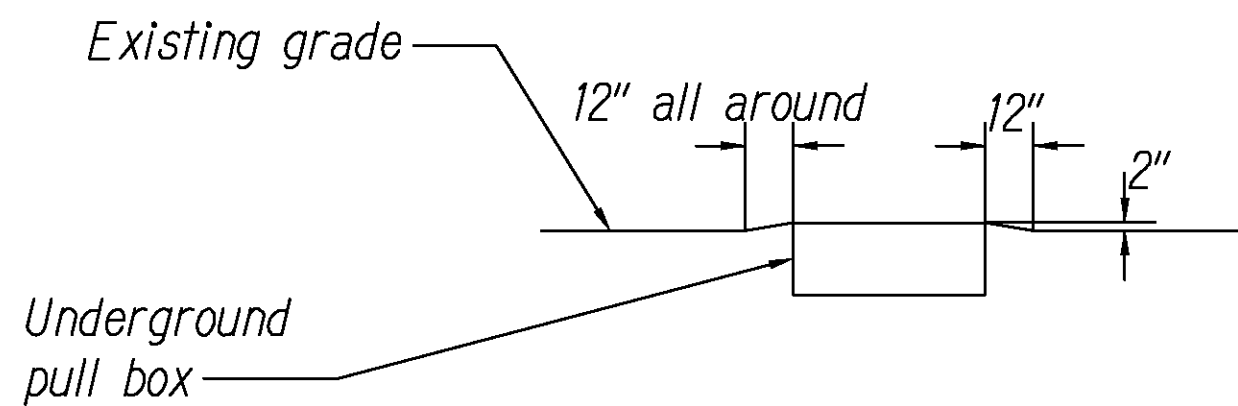

TYPICAL PULLBOX INSTALLATION

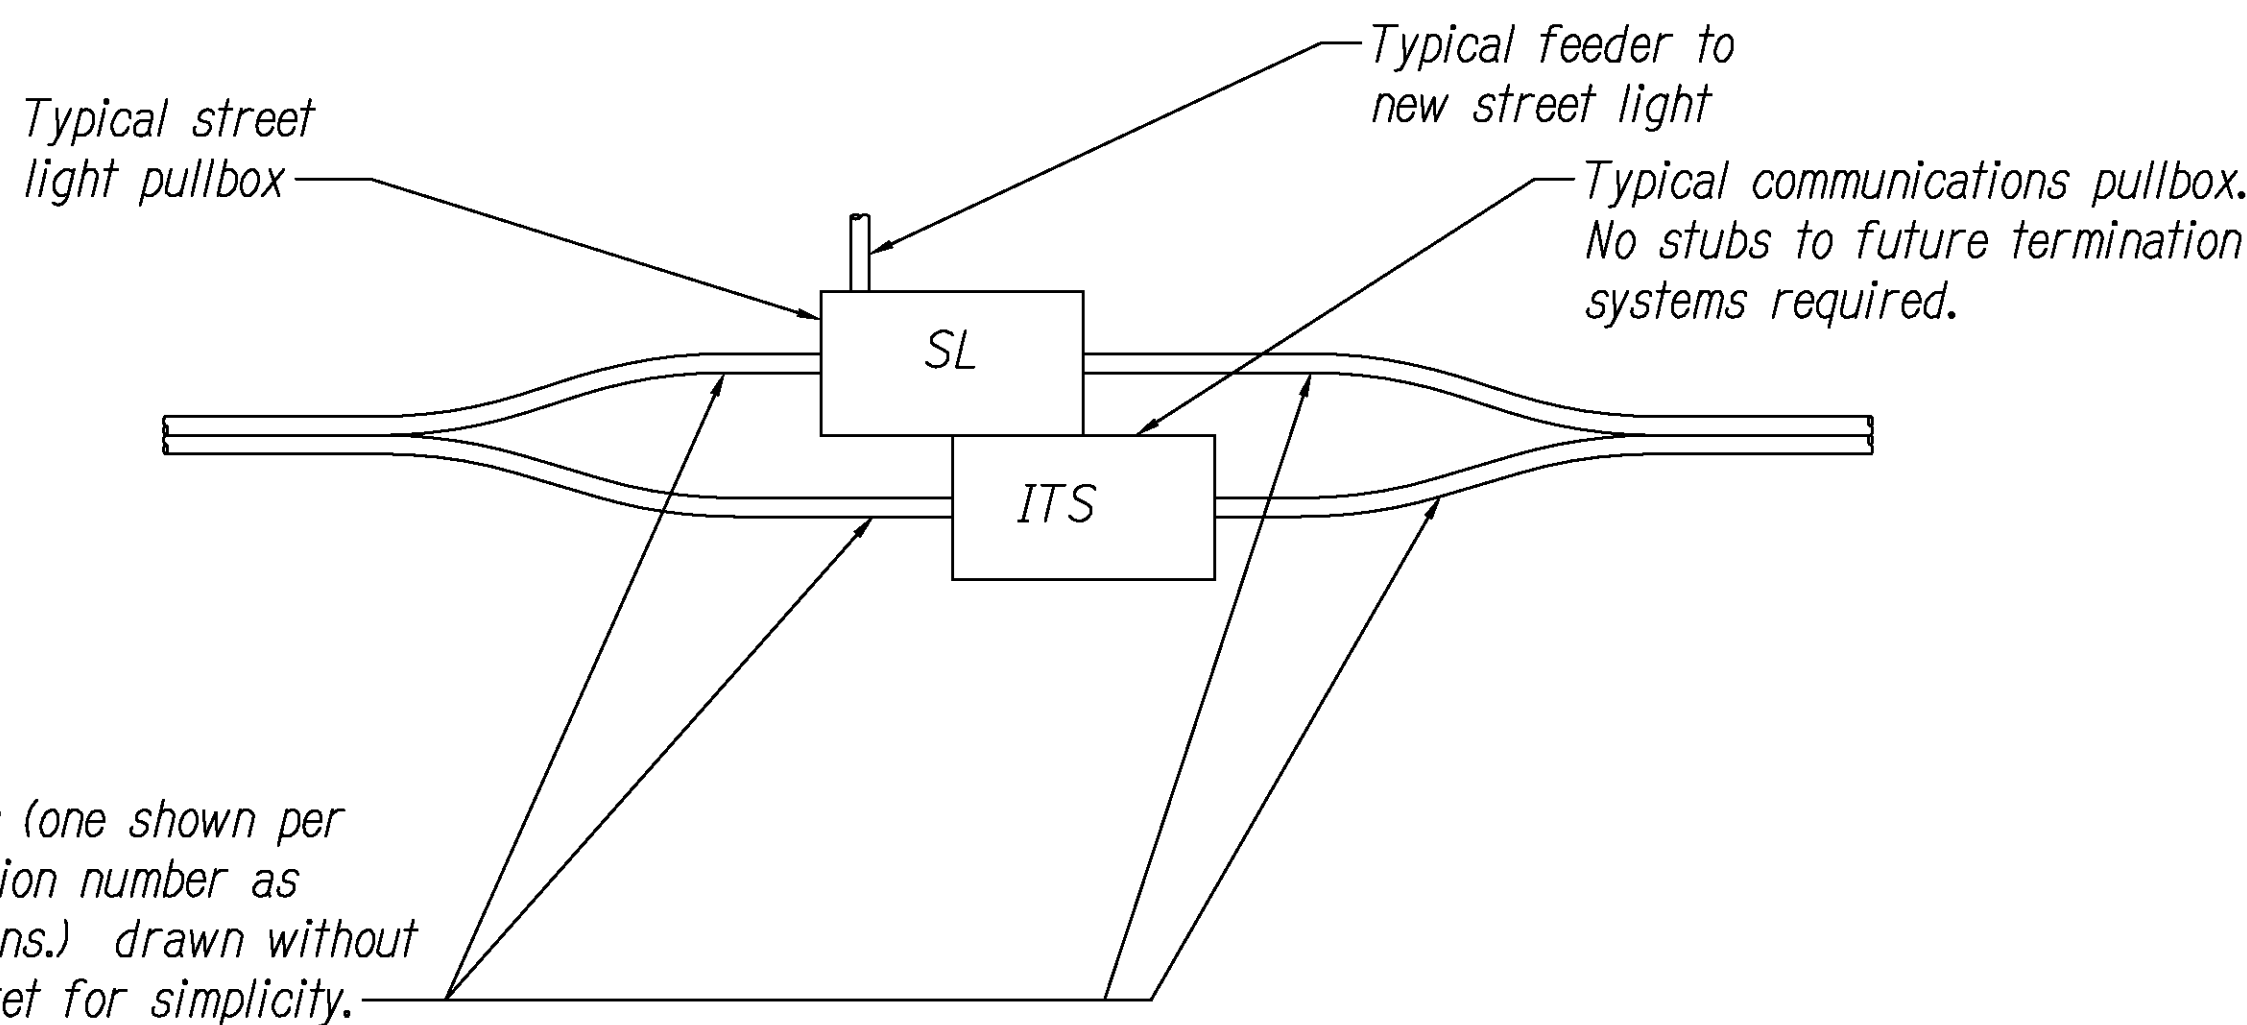

ORIGINAL PLAN	SURVEY PLOTTED BY	DATE
NOTE BOOK	DESIGNED BY	
	QUANTITIES BY	
	CHECKED BY	

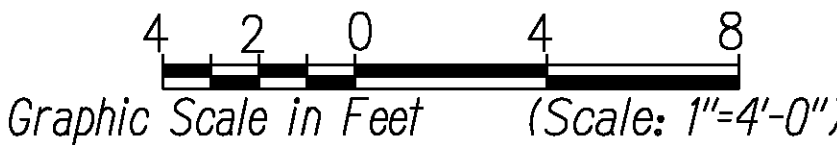

*Glenn D. Oyama*  
THIS WORK WAS PREPARED BY  
ME OR UNDER MY SUPERVISION

STATE OF HAWAII  
DEPARTMENT OF TRANSPORTATION  
HIGHWAYS DIVISION  
**HALAWA DISTRIBUTION CENTER**  
**DETAILS**  
MOANALUA FREEWAY, HIGHWAY LIGHTING IMPROVEMENTS  
Halawa to H-3 Freeway Underpass  
FAP NO. NH-H201(006)  
Scale: 1" = 4'-0" Date: July 2020  
SHEET No. E-18 OF 29 SHEETS