


FED. ROAD DIST. NO.	STATE	FED. AID PROJ. NO.	FISCAL YEAR	SHEET NO.	TOTAL SHEETS
HAWAII	HAW.	NH-H201(005) Ph2	2020	131	140

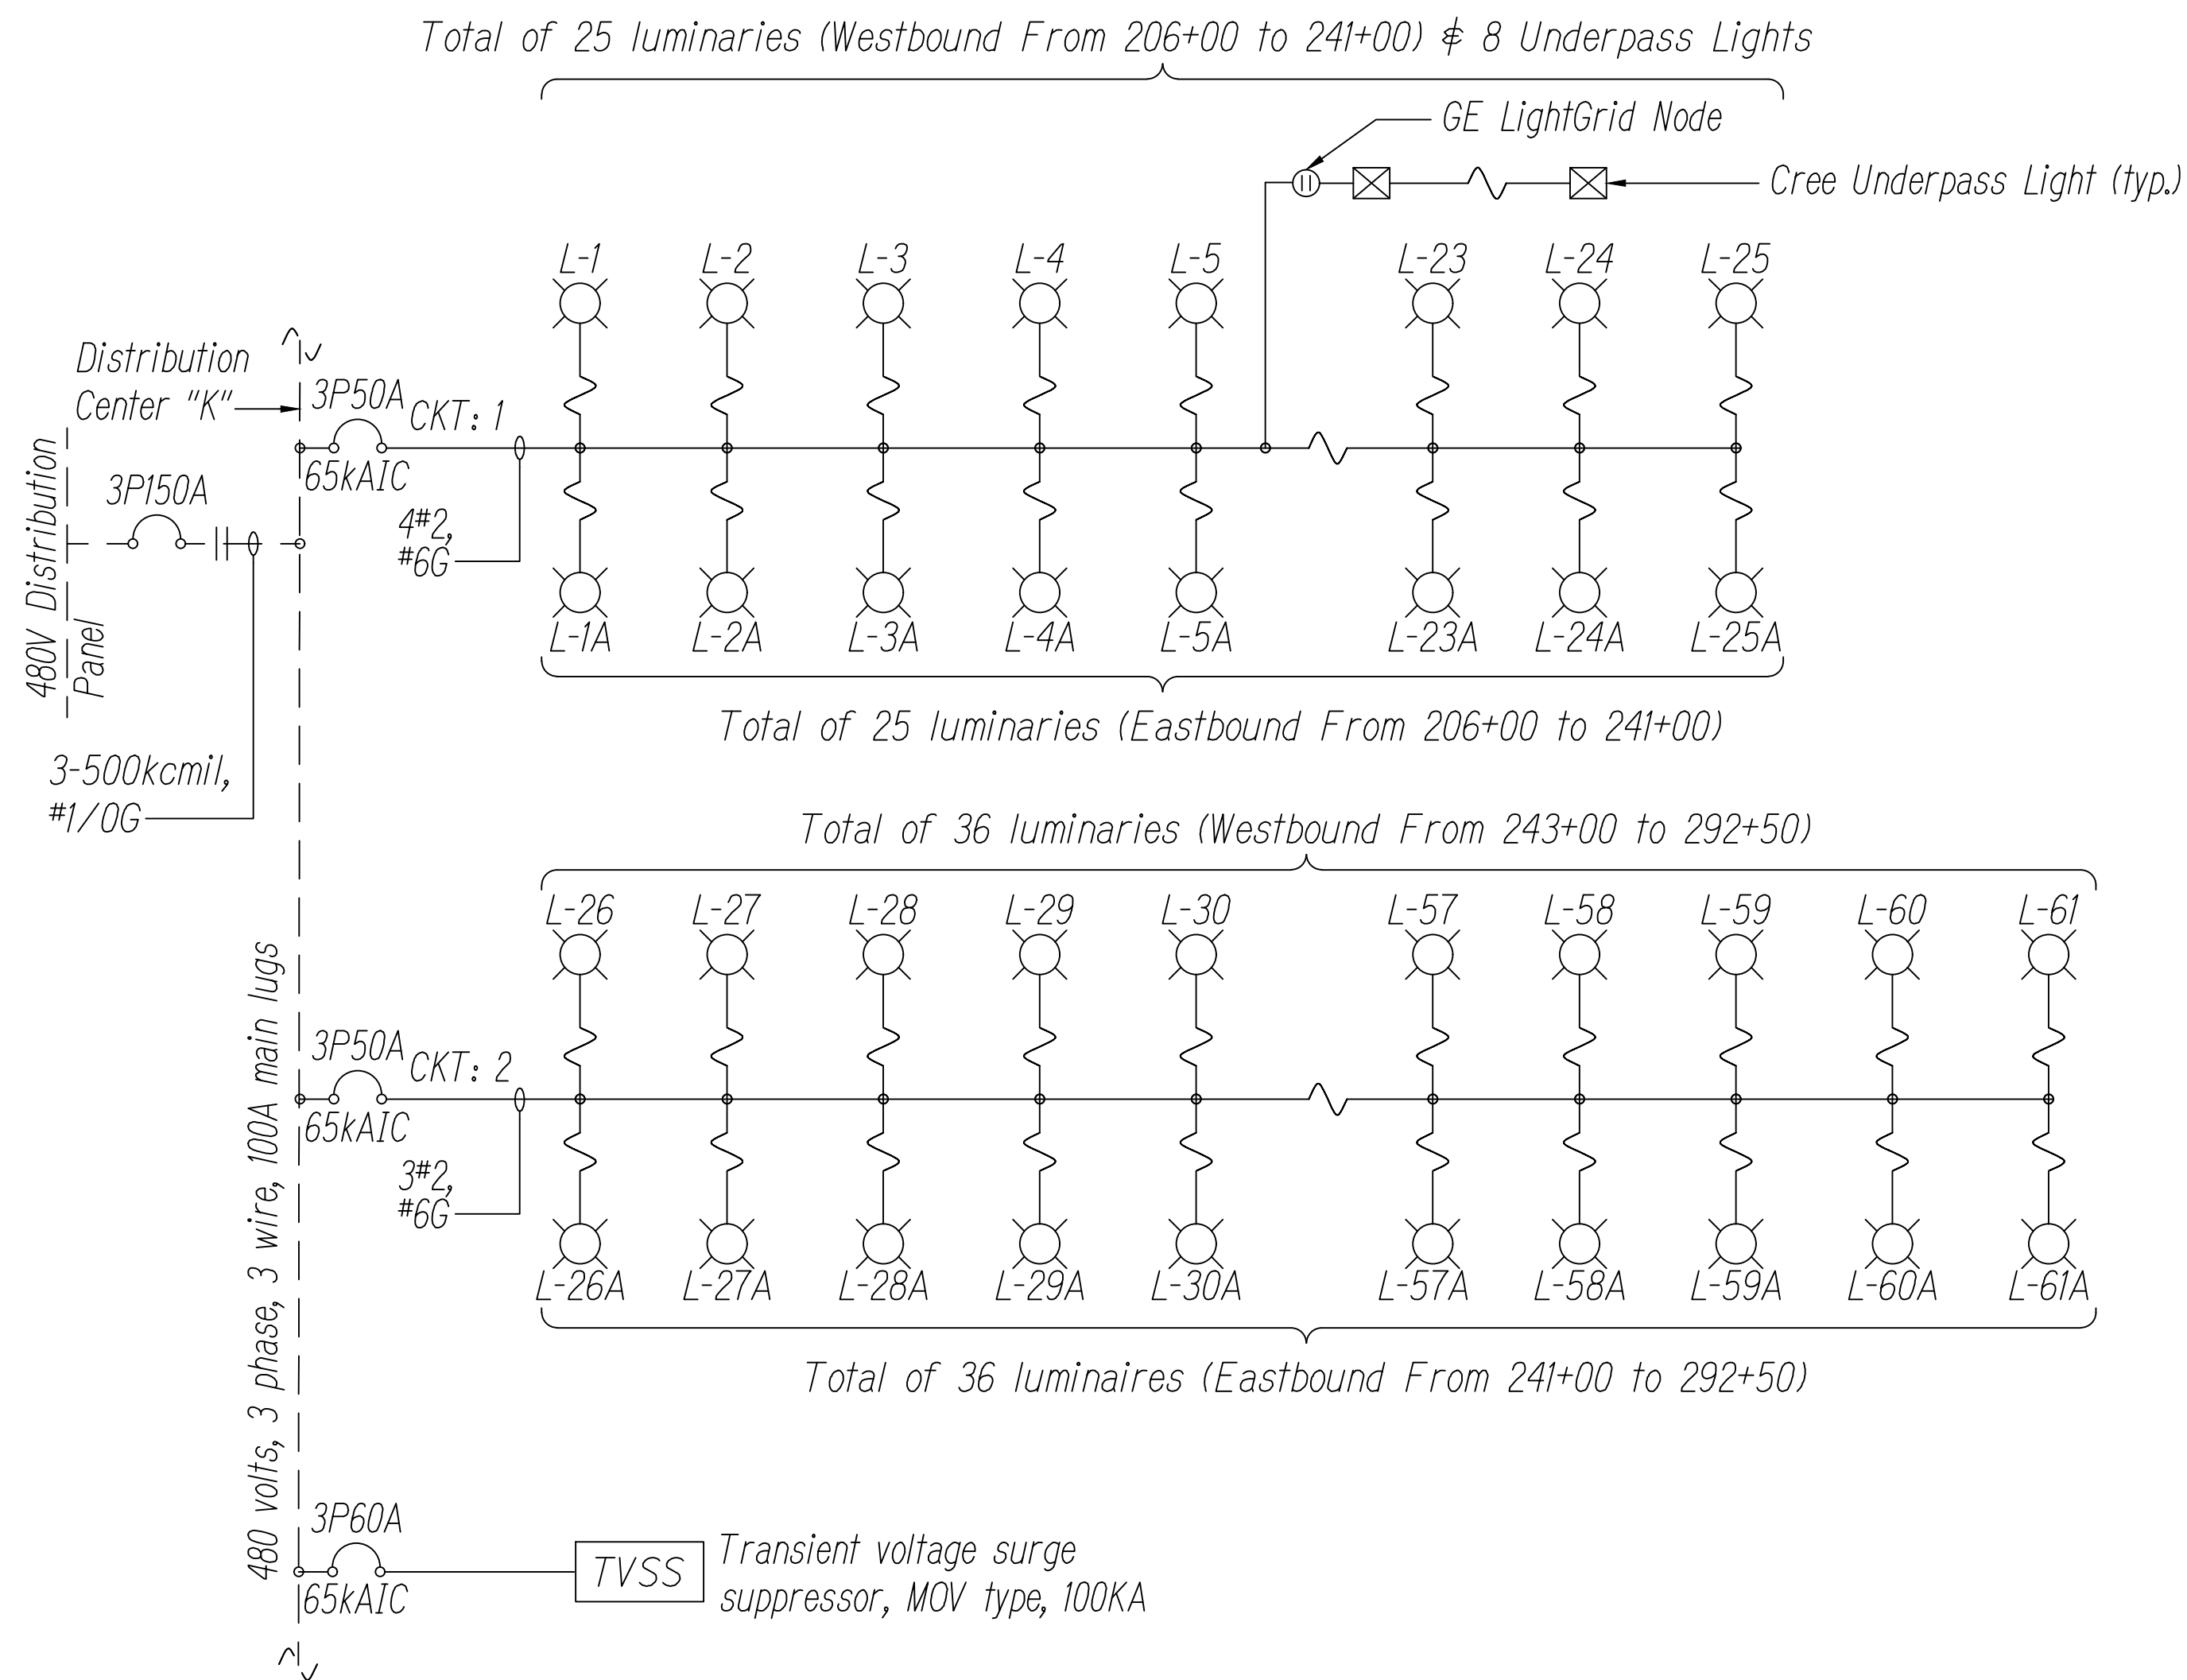


KAISER DISTRIBUTION CENTER - PARTIAL ONE-LINE DIAGRAM (ADDITIVE ALT. #1)

NO SCALE

NOTES:

- Dashed lines denote existing condition
- Solid lines denote new work

ORIGINAL PLAN	SURVEY PLOTTED BY	DATE
NOTE BOOK	DESIGNED BY	
No.	CHECKED BY	

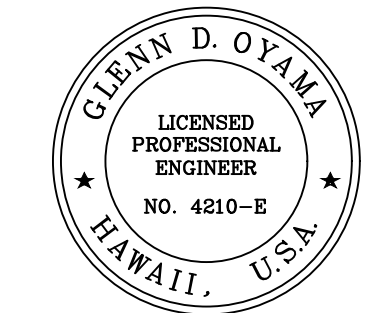

Glenn D. Oyama  
EXPIRATION DATE OF THE LICENSE 11/30/2022  
THIS WORK WAS PREPARED BY  
ME OR UNDER MY SUPERVISION

STATE OF HAWAII  
DEPARTMENT OF TRANSPORTATION  
HIGHWAYS DIVISION  
**ADD. ALT. #1 ONE-LINE  
DIAGRAM - KAISER**  
MOANALUA FREEWAY, HIGHWAY LIGHTING IMPROVEMENTS  
Halawa Heights Off-ramp to Middle St. Overpass  
FAP NO. NH-H201(005) PHASE 2  
Scale: Date: July 2020  
SHEET No. E-30 OF 39 SHEETS

