



FED. ROAD DIST. NO.	STATE	FED. AID PROJ. NO.	FISCAL YEAR	SHEET NO.	TOTAL SHEETS
HAWAII	HAW.	NH-H201(005) Ph2	2020	104	140

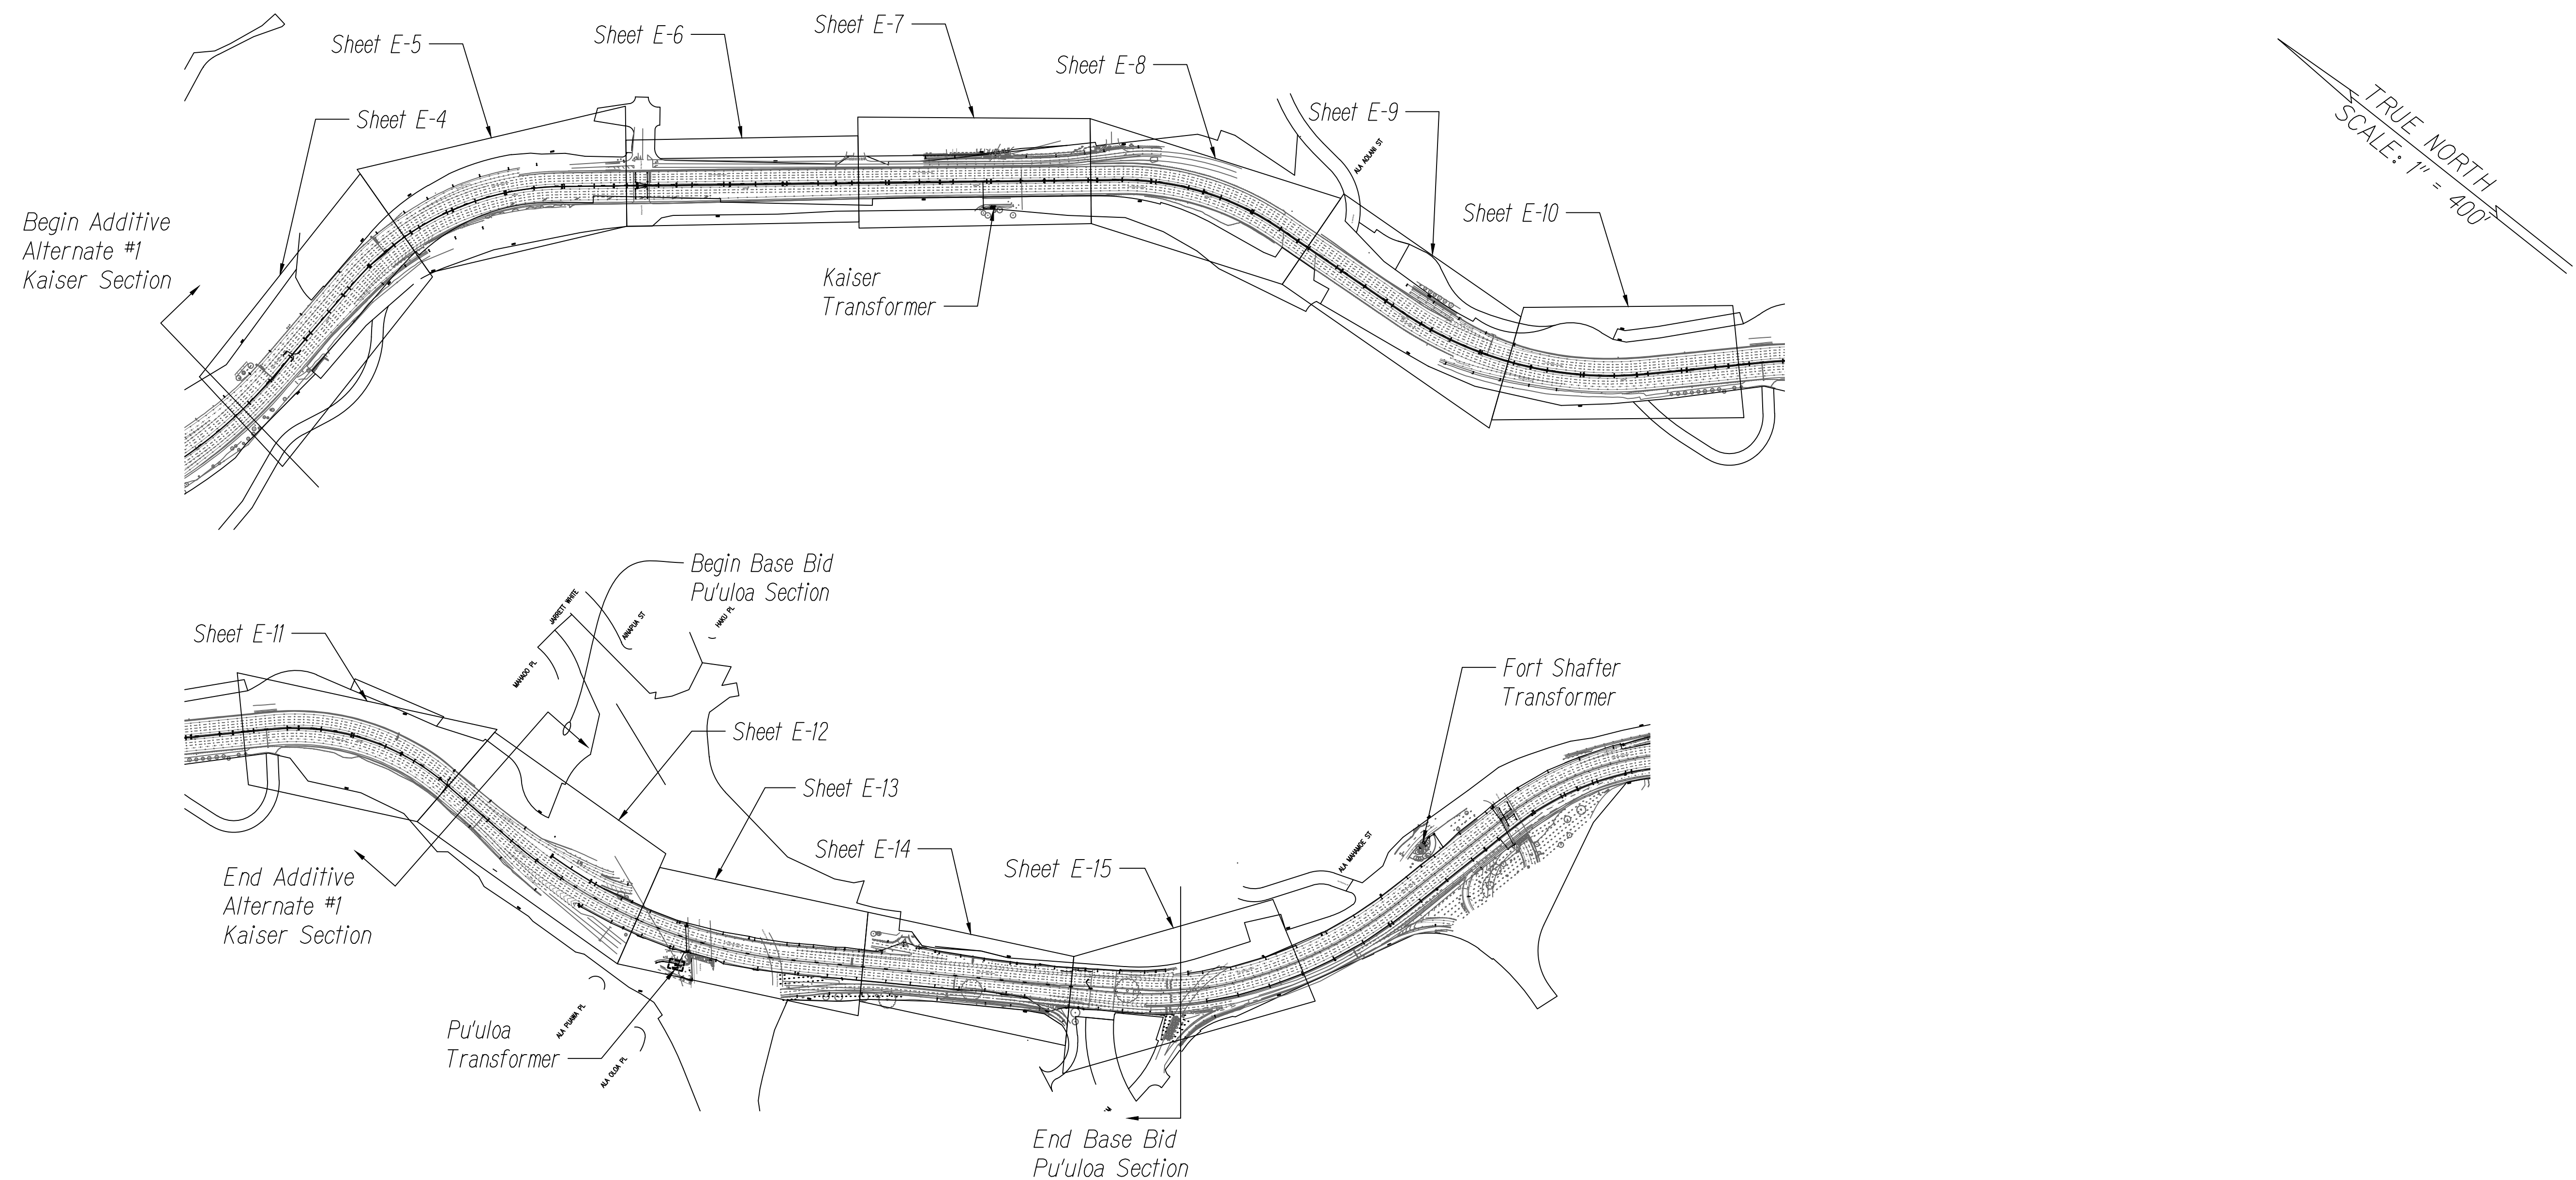

H-201 KEY MAP
Scale 1"=400'

ORIGINAL PLAN	SURVEY PLOTTED BY	DATE
	DRAWN BY	
	DESIGNED BY	
	QUANTITIES BY	
NOTE BOOK	CHECKED BY	
	No.	

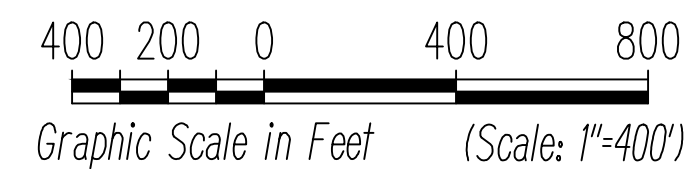

Glenn D. Oyama
EXPIRATION DATE OF THE LICENSE 11/30/2022
THIS WORK WAS PREPARED BY
ME OR UNDER MY SUPERVISION

STATE OF HAWAII
DEPARTMENT OF TRANSPORTATION
HIGHWAYS DIVISION


KEY MAP

MOANALUA FREEWAY, HIGHWAY LIGHTING IMPROVEMENTS
Halawa Heights Off-ramp to Middle St. Overpass
FAP NO. NH-H201(005) PHASE 2

Scale: 1" = 400'-0" Date: July 2020

SHEET No. *E-3* OF 39 SHEETS

FED. ROAD DIST. NO.	STATE	FED. AID PROJ. NO.	FISCAL YEAR	SHEET NO.	TOTAL SHEETS
HAWAII	HAW.	NH-H201(005) Ph2	2020	105	140

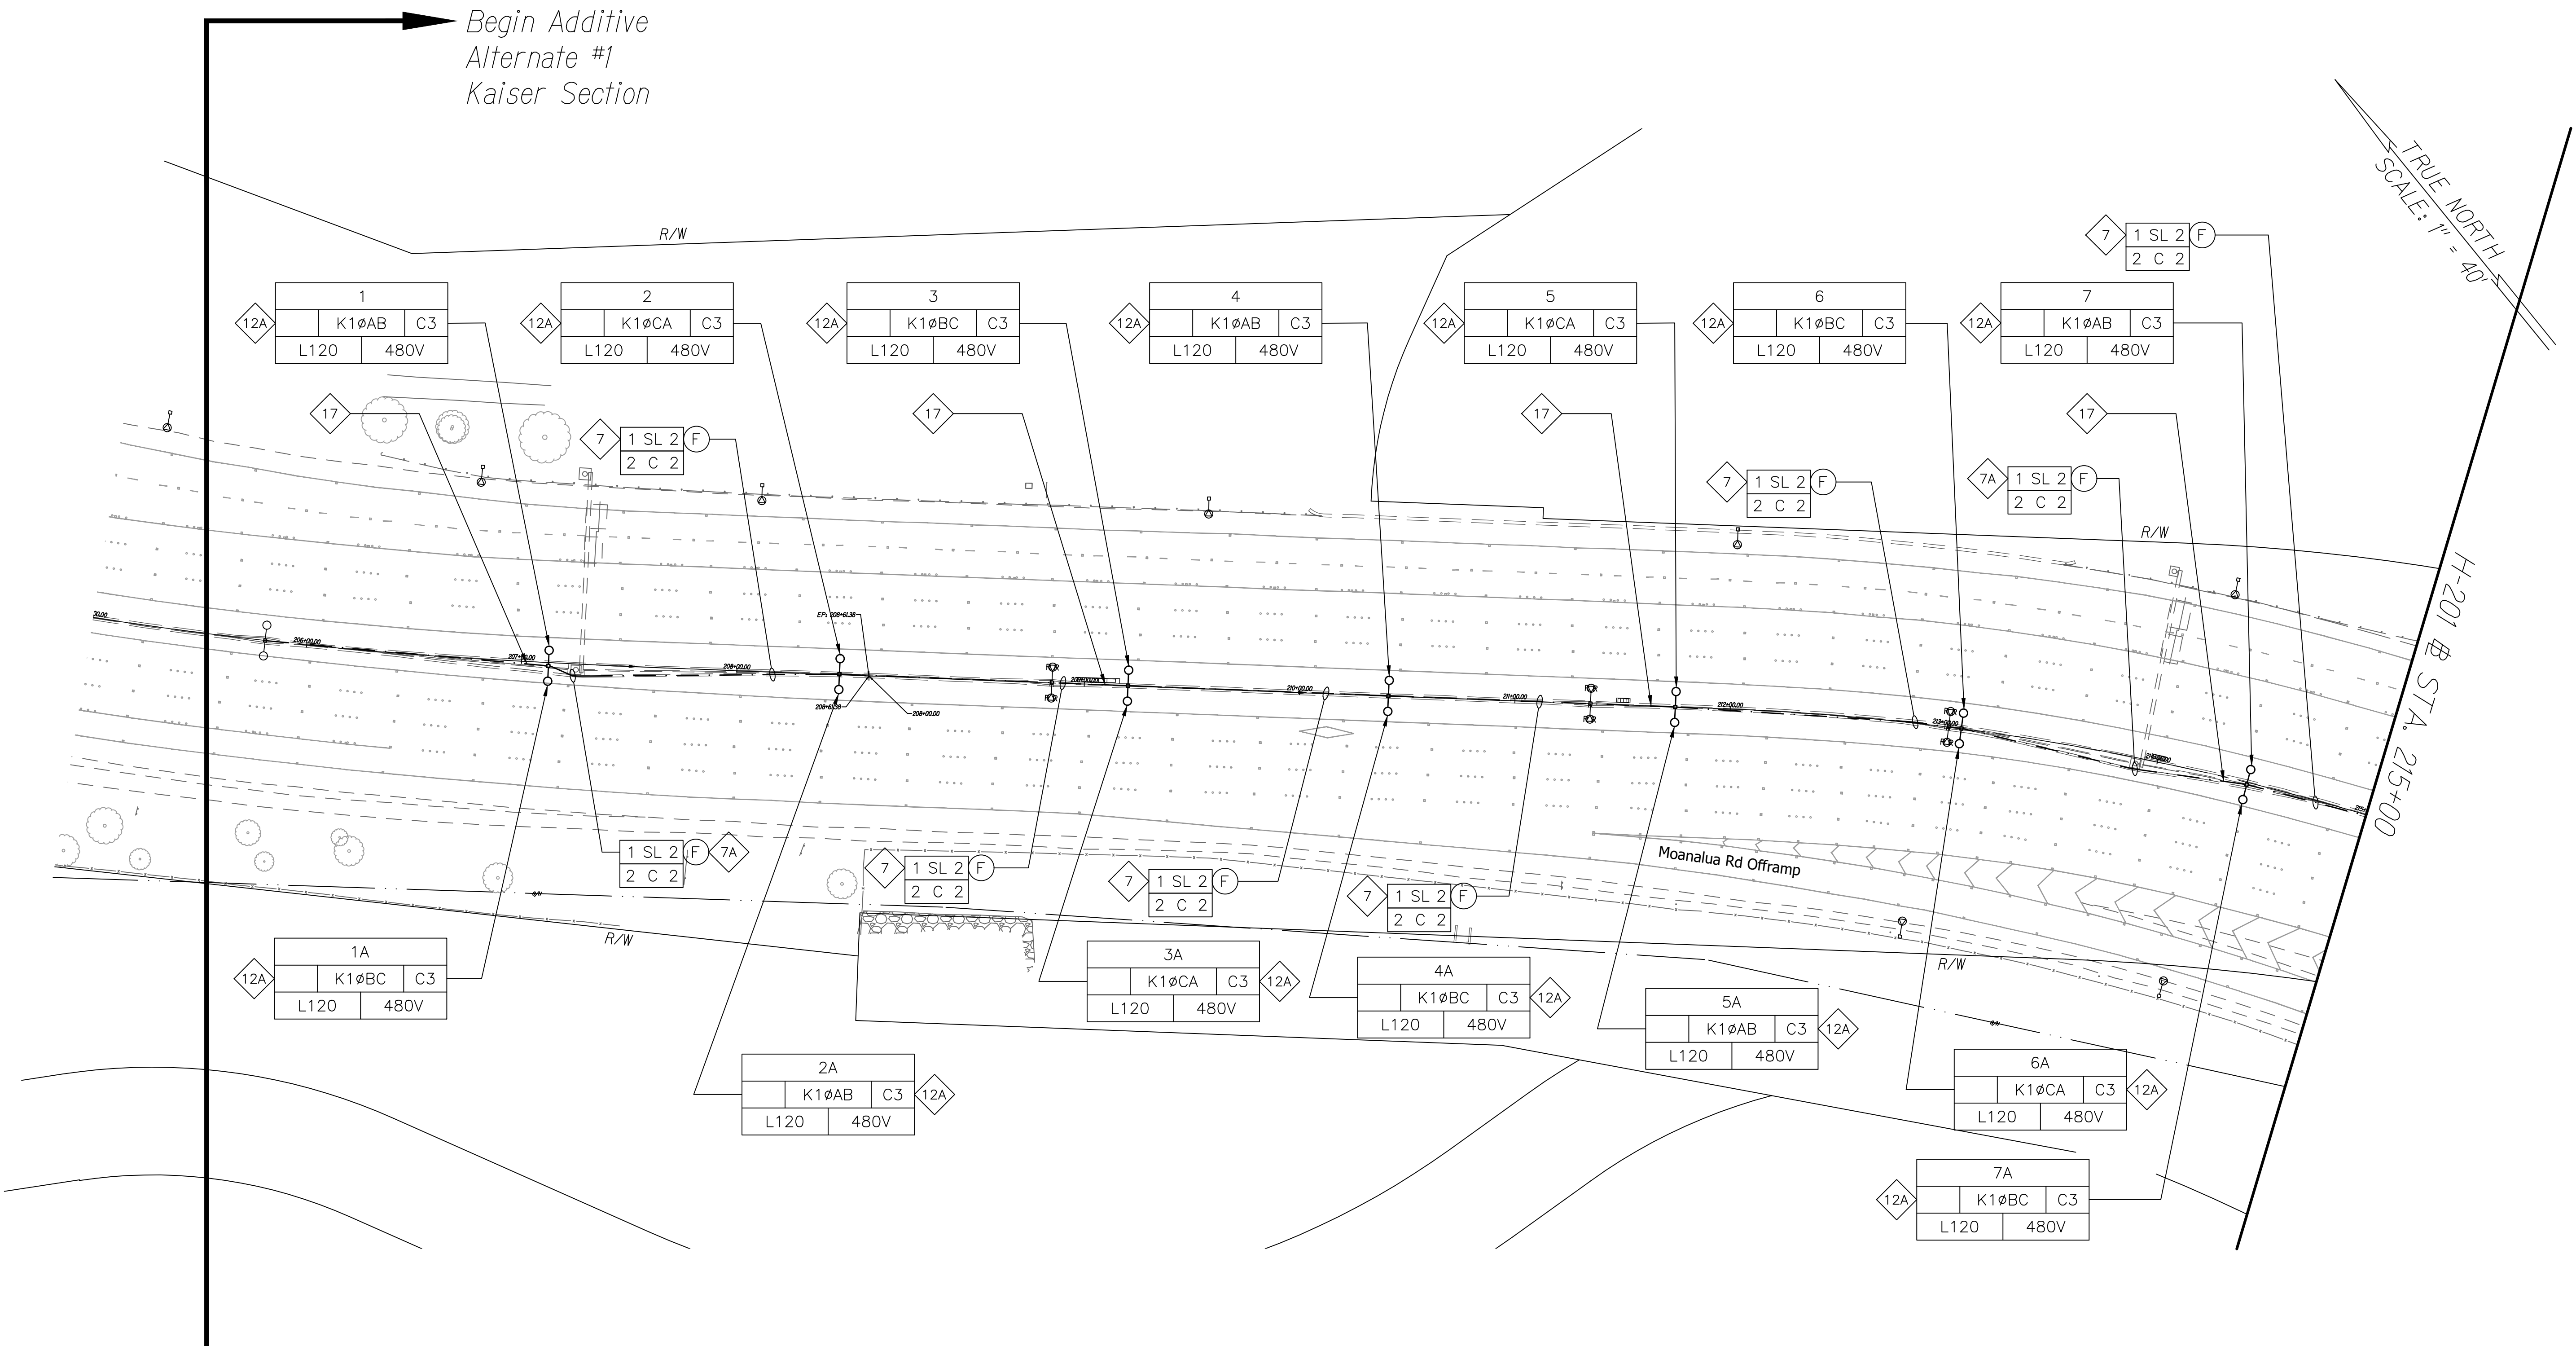

ORIGINAL PLAN	DATE
NOTE BOOK	
DESIGNED BY	
QUANTITIES BY	
CHECKED BY	


H-201 LIGHTING PLAN-1 (ADDITIVE ALT. #1)
Scale 1"=40'-0"



Glenn D. Oyama
EXPIRATION DATE OF THE LICENSE 4/30/2022
THIS WORK WAS PREPARED BY
ME OR UNDER MY SUPERVISION

STATE OF HAWAII
DEPARTMENT OF TRANSPORTATION
HIGHWAYS DIVISION
H-201 ADD. ALT. #1 LIGHTING
PLAN STA. 205+00 TO 215+00
MOANALUA FREEWAY, HIGHWAY LIGHTING IMPROVEMENTS
Halawa Heights Off-ramp to Middle St. Overpass
FAP NO. NH-H201(005) PHASE 2
Scale: 1" = 40'-0" Date: July 2020
SHEET No. E-4 OF 39 SHEETS


FED. ROAD DIST. NO.	STATE	FED. AID PROJ. NO.	FISCAL YEAR	SHEET NO.	TOTAL SHEETS
HAWAII	HAW.	NH-H201(005) Ph2	2020	106	140

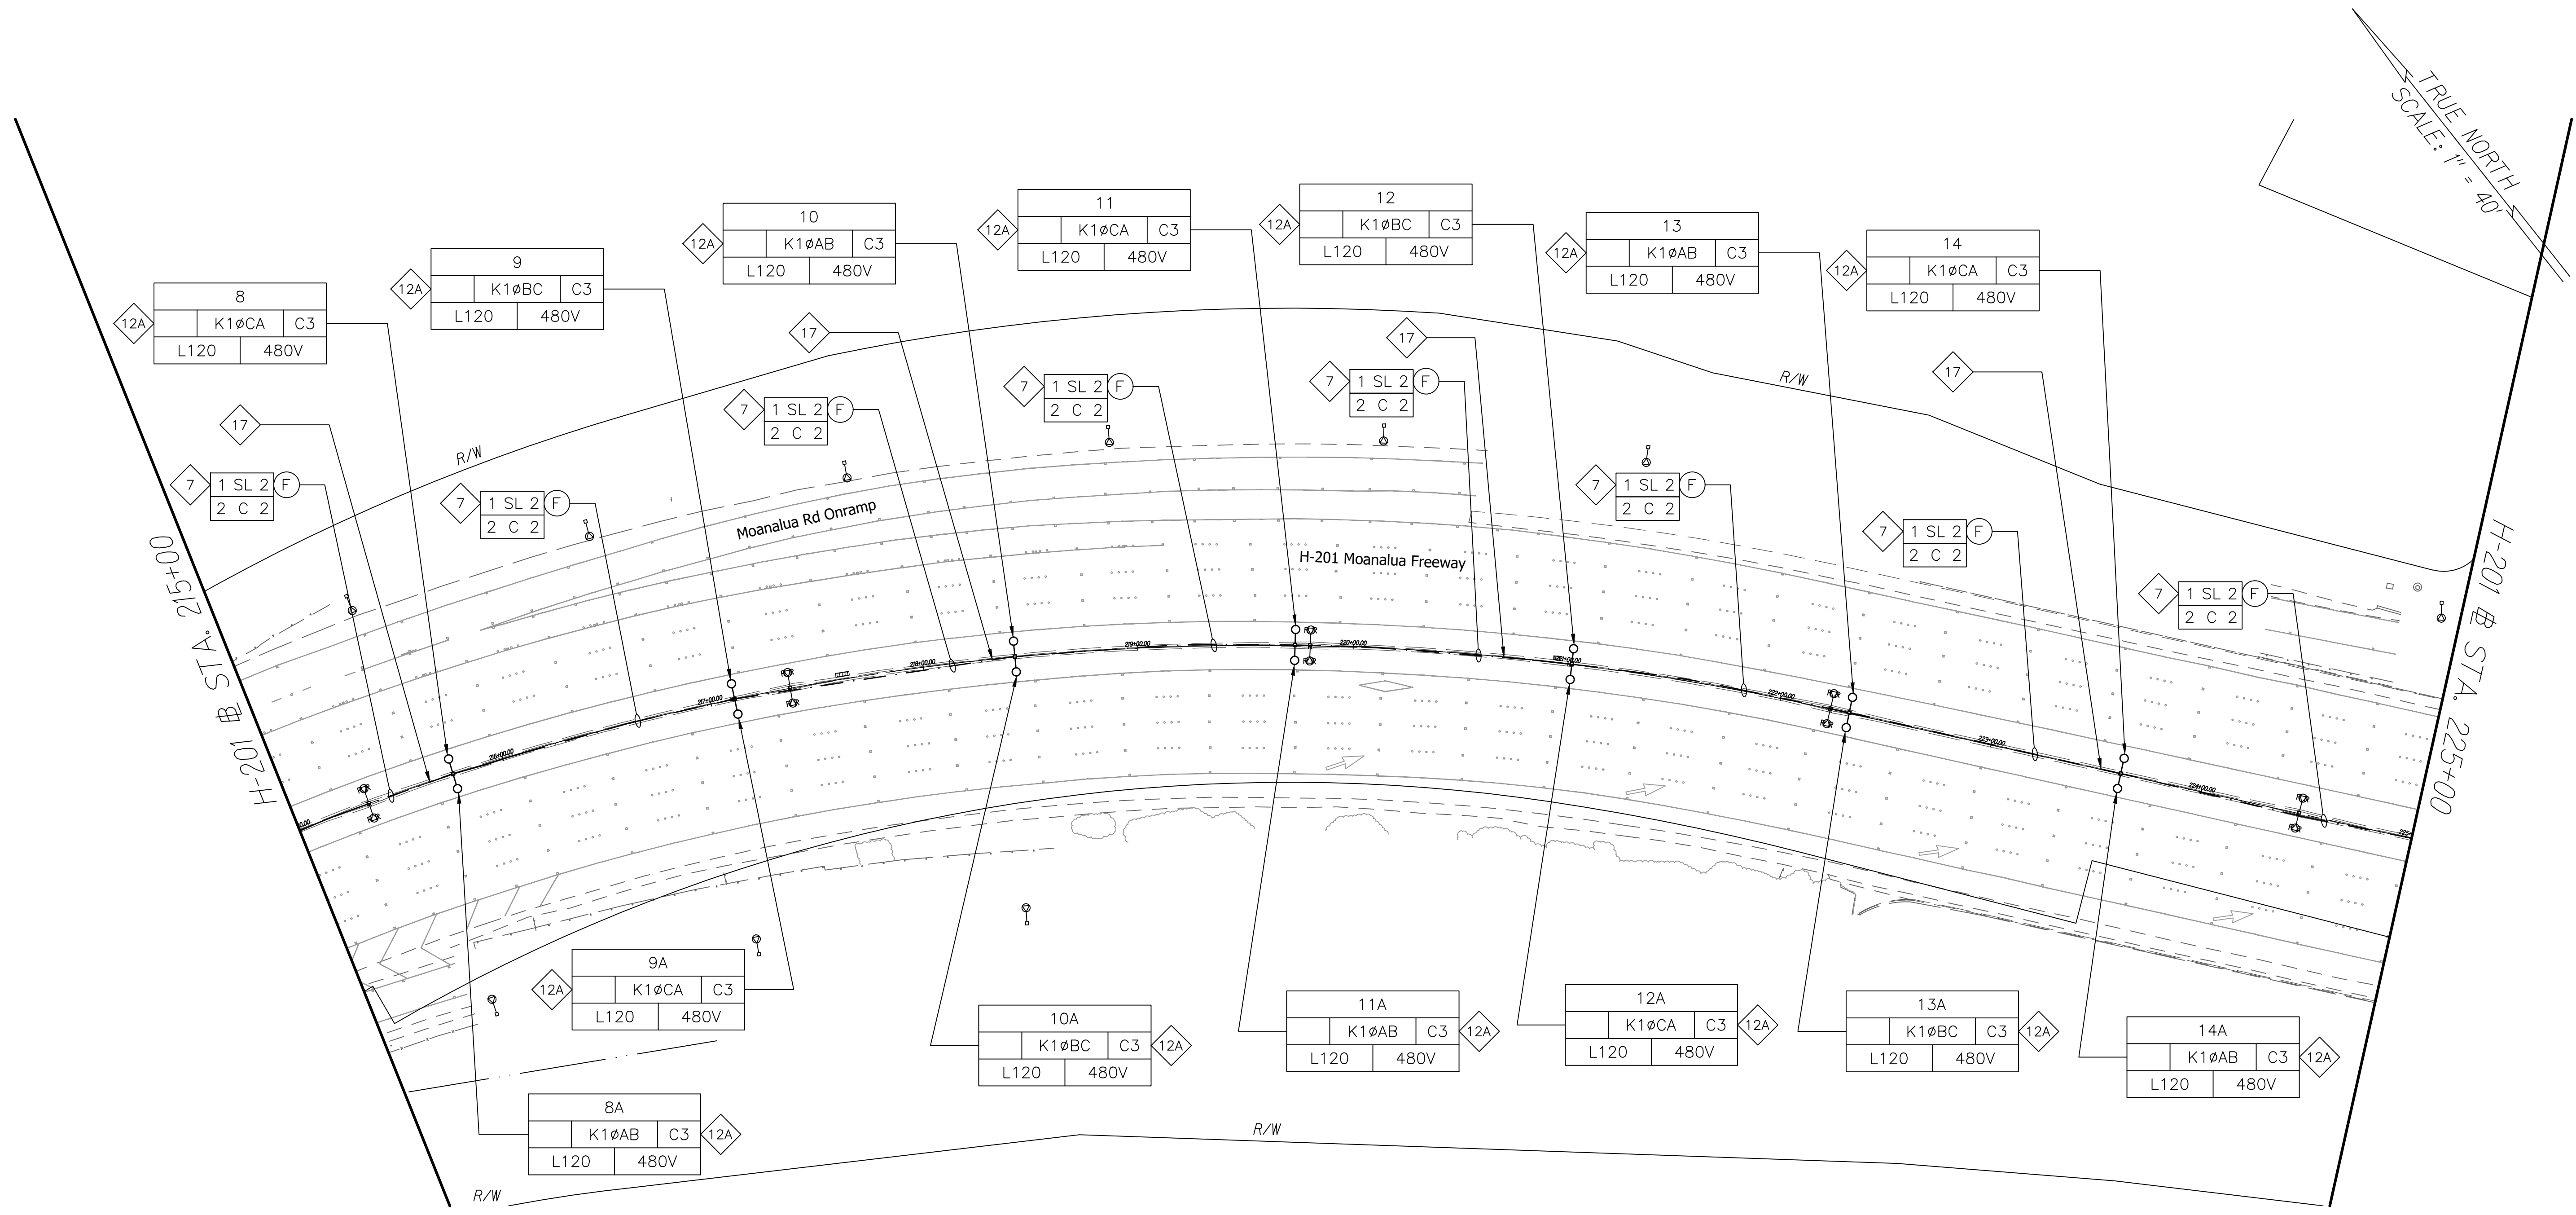

TRUE NORTH
SCALE: 1" = 40'

ORIGINAL PLAN	SURVEY PLOTTED BY	DATE
	DESIGNED BY	
	QUANTITIES BY	
	CHECKED BY	



H-201 LIGHTING PLAN-2 (ADDITIVE ALT. #1)
Scale 1"=40'-0"

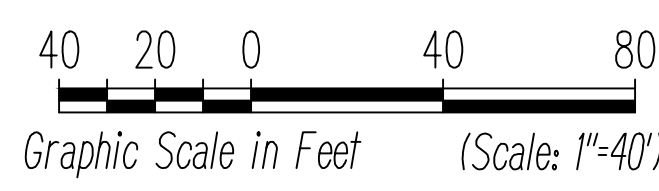

GLENN D. OYAMA
LICENSED PROFESSIONAL ENGINEER
NO. 4210-E
HAWAII, U.S.A.
Glenn D. Oyama
EXPIRATION DATE OF THE LICENSE: 4/30/2022
THIS WORK WAS PREPARED BY ME OR UNDER MY SUPERVISION


STATE OF HAWAII
DEPARTMENT OF TRANSPORTATION
HIGHWAYS DIVISION
H-201 ADD. ALT. #1 LIGHTING
PLAN STA. 215+00 TO 225+00
MOANALUA FREEWAY, HIGHWAY LIGHTING IMPROVEMENTS
Halawa Heights Off-ramp to Middle St. Overpass
FAP NO. NH-H201(005) PHASE 2
Scale: 1" = 40'-0" Date: July 2020
SHEET No. E-5 OF 39 SHEETS

FED. ROAD DIST. NO.	STATE	FED. AID PROJ. NO.	FISCAL YEAR	SHEET NO.	TOTAL SHEETS
HAWAII	HAW.	NH-H201(005) Ph2	2020	107	140

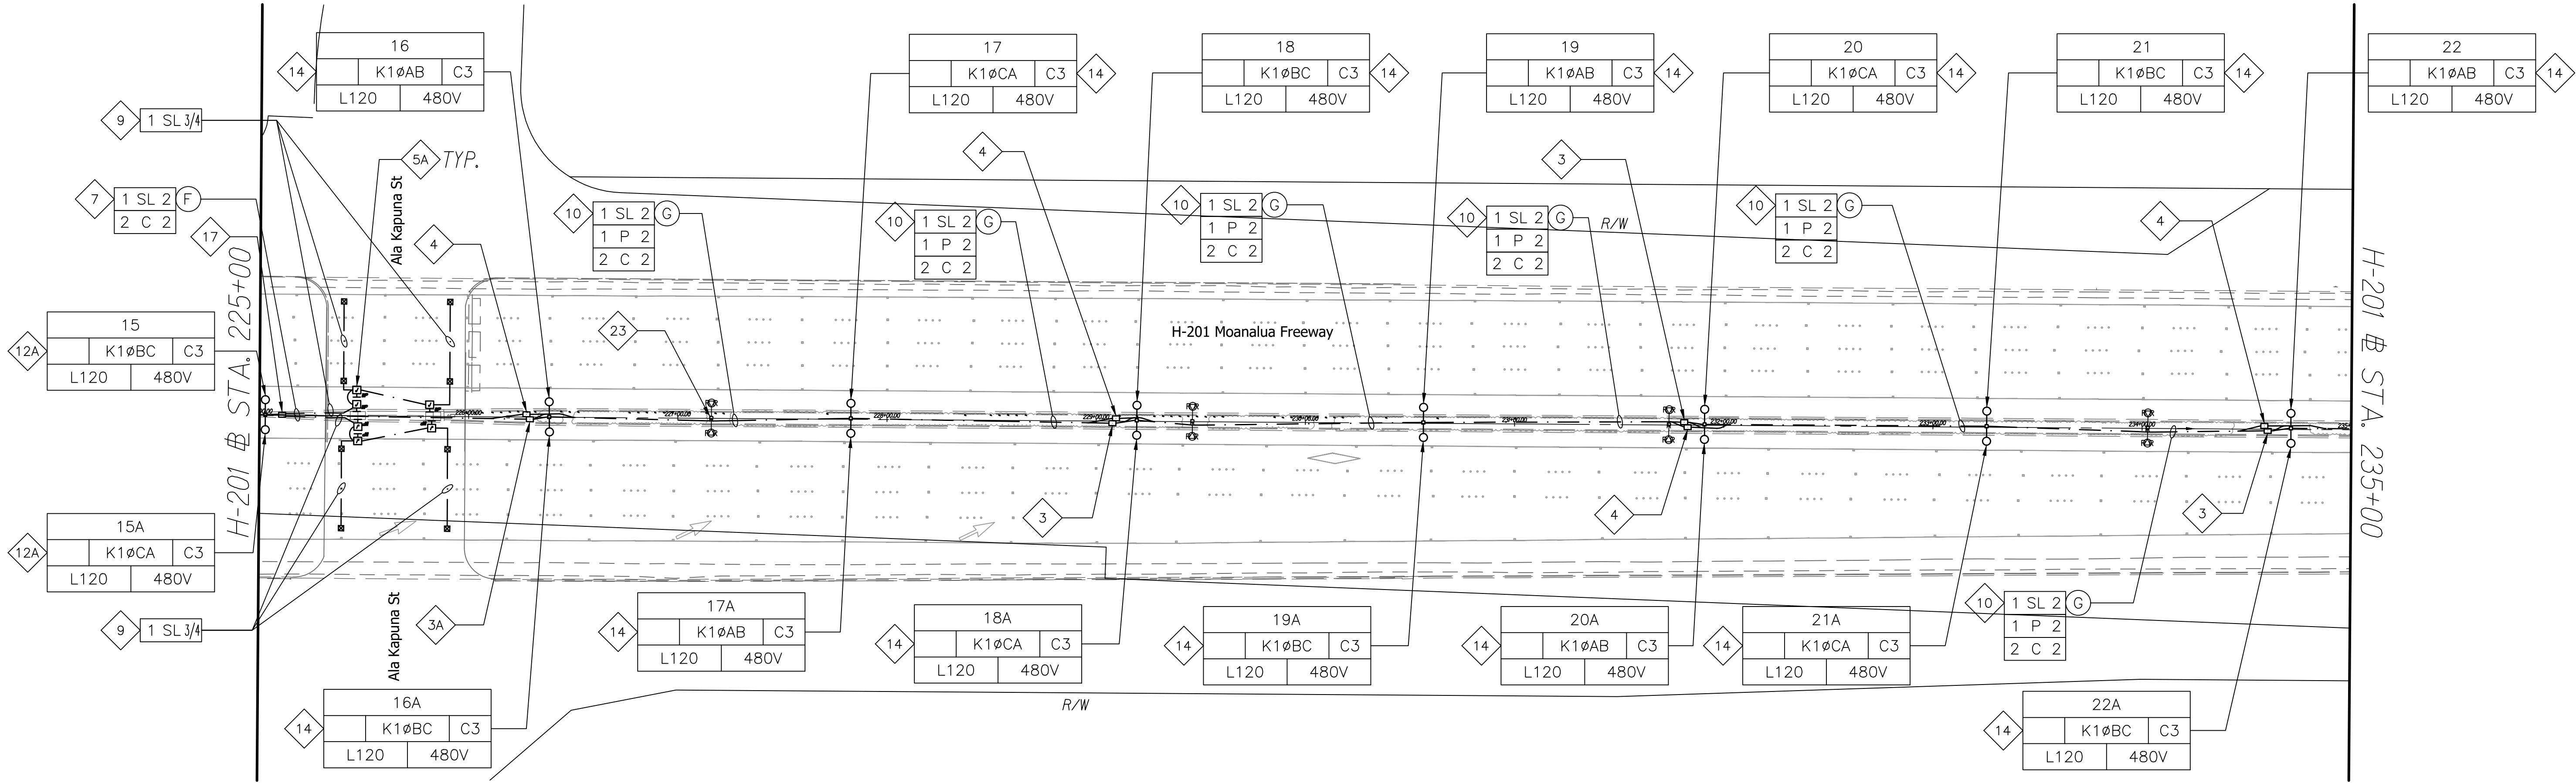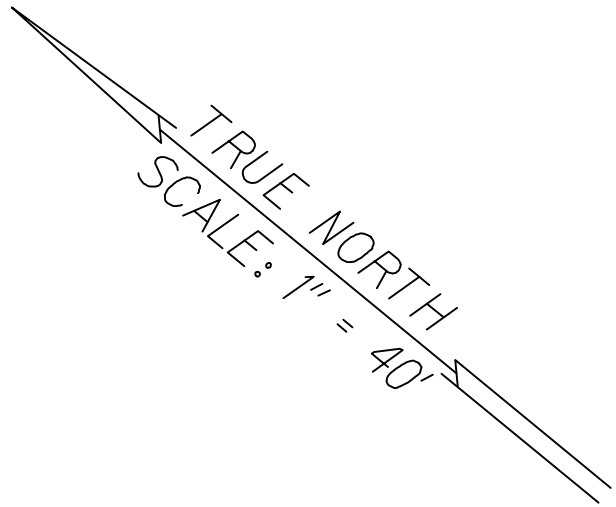

ORIGINAL PLAN	SURVEY PLOTTED BY	DATE
	DRAWN BY	
	DESIGNED BY	
	QUANTITIES BY	
NOTE BOOK	CHECKED BY	
	No.	


H-201 LIGHTING PLAN-3 (ADDITIVE ALT. #1)
Scale 1"=40'-0"

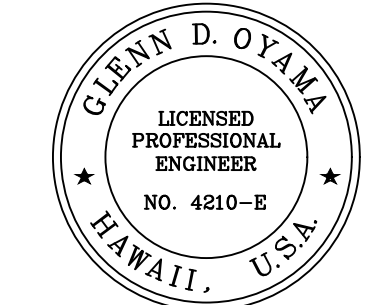

Glenn D. Oyama
EXPIRATION DATE OF THE LICENSE 11/30/2022
THIS WORK WAS PREPARED BY
ME OR UNDER MY SUPERVISION


STATE OF HAWAII
DEPARTMENT OF TRANSPORTATION
HIGHWAYS DIVISION
H-201 ADD. ALT. #1 LIGHTING
PLAN STA. 225+00 TO 235+00
MOANALUA FREEWAY, HIGHWAY LIGHTING IMPROVEMENTS
Halawa Heights Off-ramp to Middle St. Overpass
FAP NO. NH-H201(005) PHASE 2
Scale: 1" = 40'-0" Date: July 2020
SHEET No. E-6 OF 39 SHEETS

FED. ROAD DIST. NO.	STATE	FED. AID PROJ. NO.	FISCAL YEAR	SHEET NO.	TOTAL SHEETS
HAWAII	HAW.	NH-H201(005) Ph2	2020	108	140

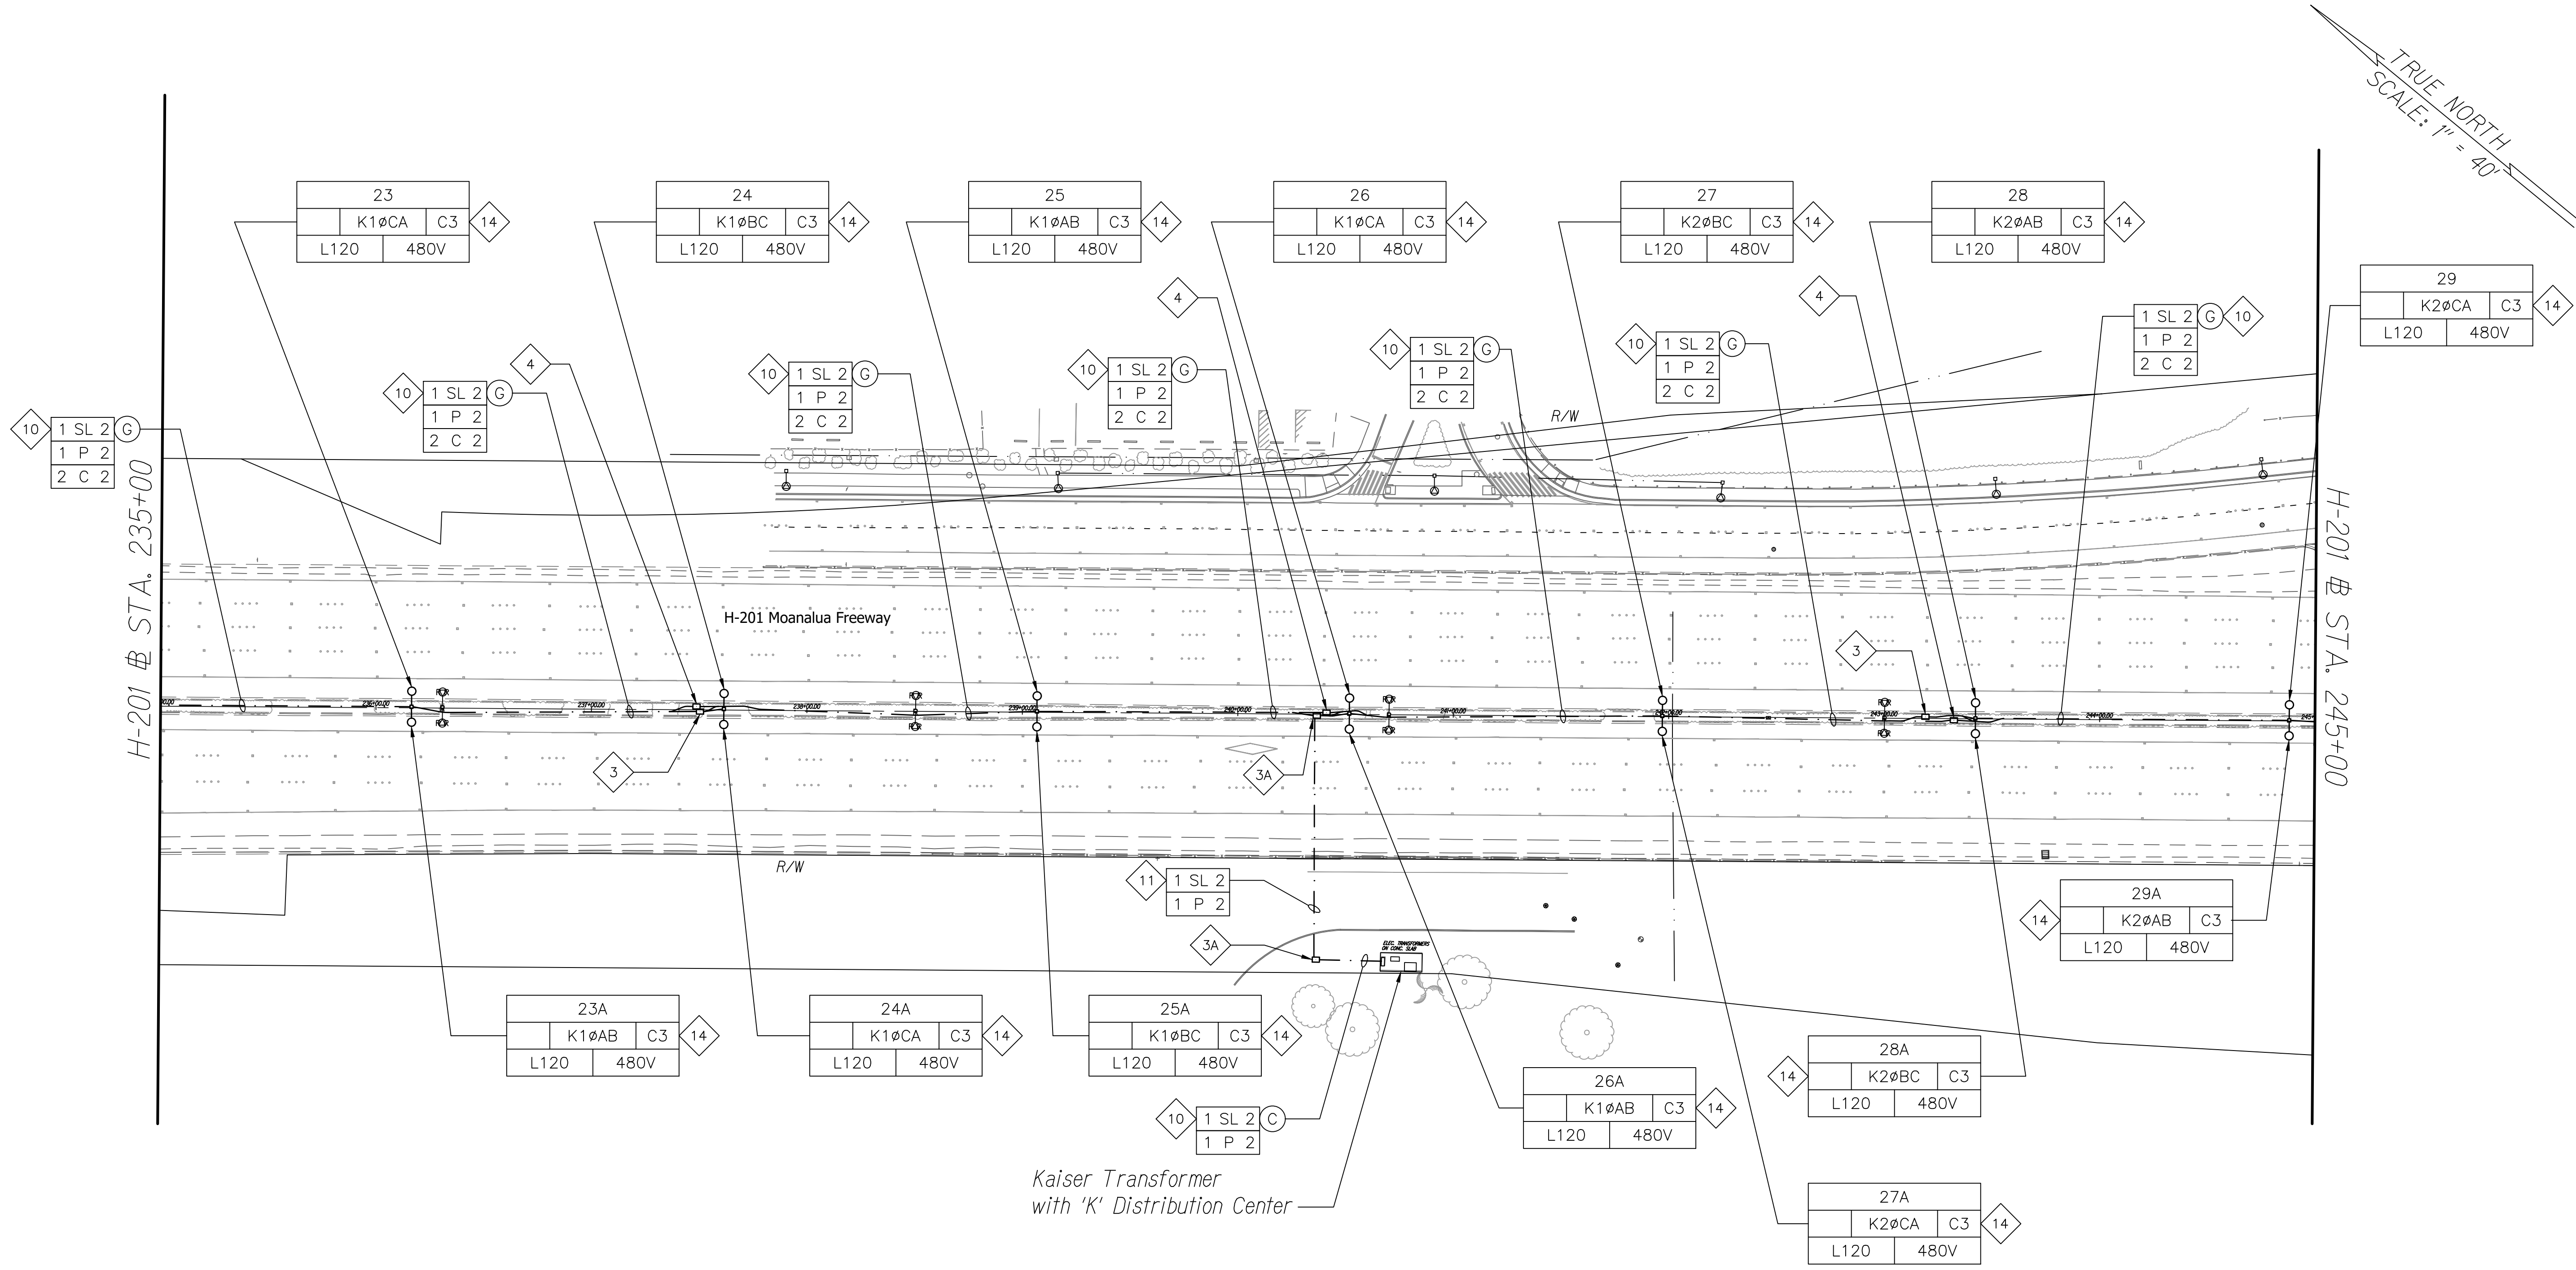

ORIGINAL PLAN	SURVEY PLOTTED BY	DATE
	DRAWN BY	
	DESIGNED BY	
	CHECKED BY	
NOTE BOOK	QUANTITIES BY	
	CHECKED BY	
No.		

H-201 LIGHTING PLAN-4 (ADDITIVE ALT. #1)
Scale 1"=40'-0"

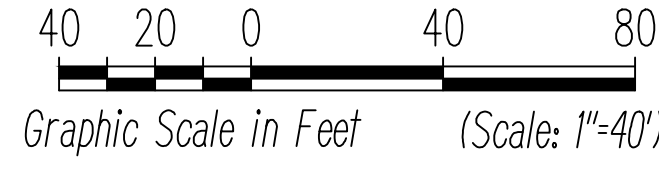


GLENN D. OYAMA
LICENSED PROFESSIONAL ENGINEER
NO. 4210-E
HAWAII, U.S.A.

Glenn D. Oyama
EXPIRATION DATE OF THE LICENSE 11/30/2022
THIS WORK WAS PREPARED BY ME OR UNDER MY SUPERVISION



STATE OF HAWAII
DEPARTMENT OF TRANSPORTATION
HIGHWAYS DIVISION
H-201 ADD. ALT. #1 LIGHTING
PLAN STA. 235+00 TO 245+00
MOANALUA FREEWAY, HIGHWAY LIGHTING IMPROVEMENTS
Halawa Heights Off-ramp to Middle St. Overpass
FAP NO. NH-H201(005) PHASE 2
Scale: 1" = 40'-0" Date: July 2020
SHEET No. E-7 OF 39 SHEETS

FED. ROAD DIST. NO.	STATE	FED. AID PROJ. NO.	FISCAL YEAR	SHEET NO.	TOTAL SHEETS
HAWAII	HAW.	NH-H201(005) Ph2	2020	109	140

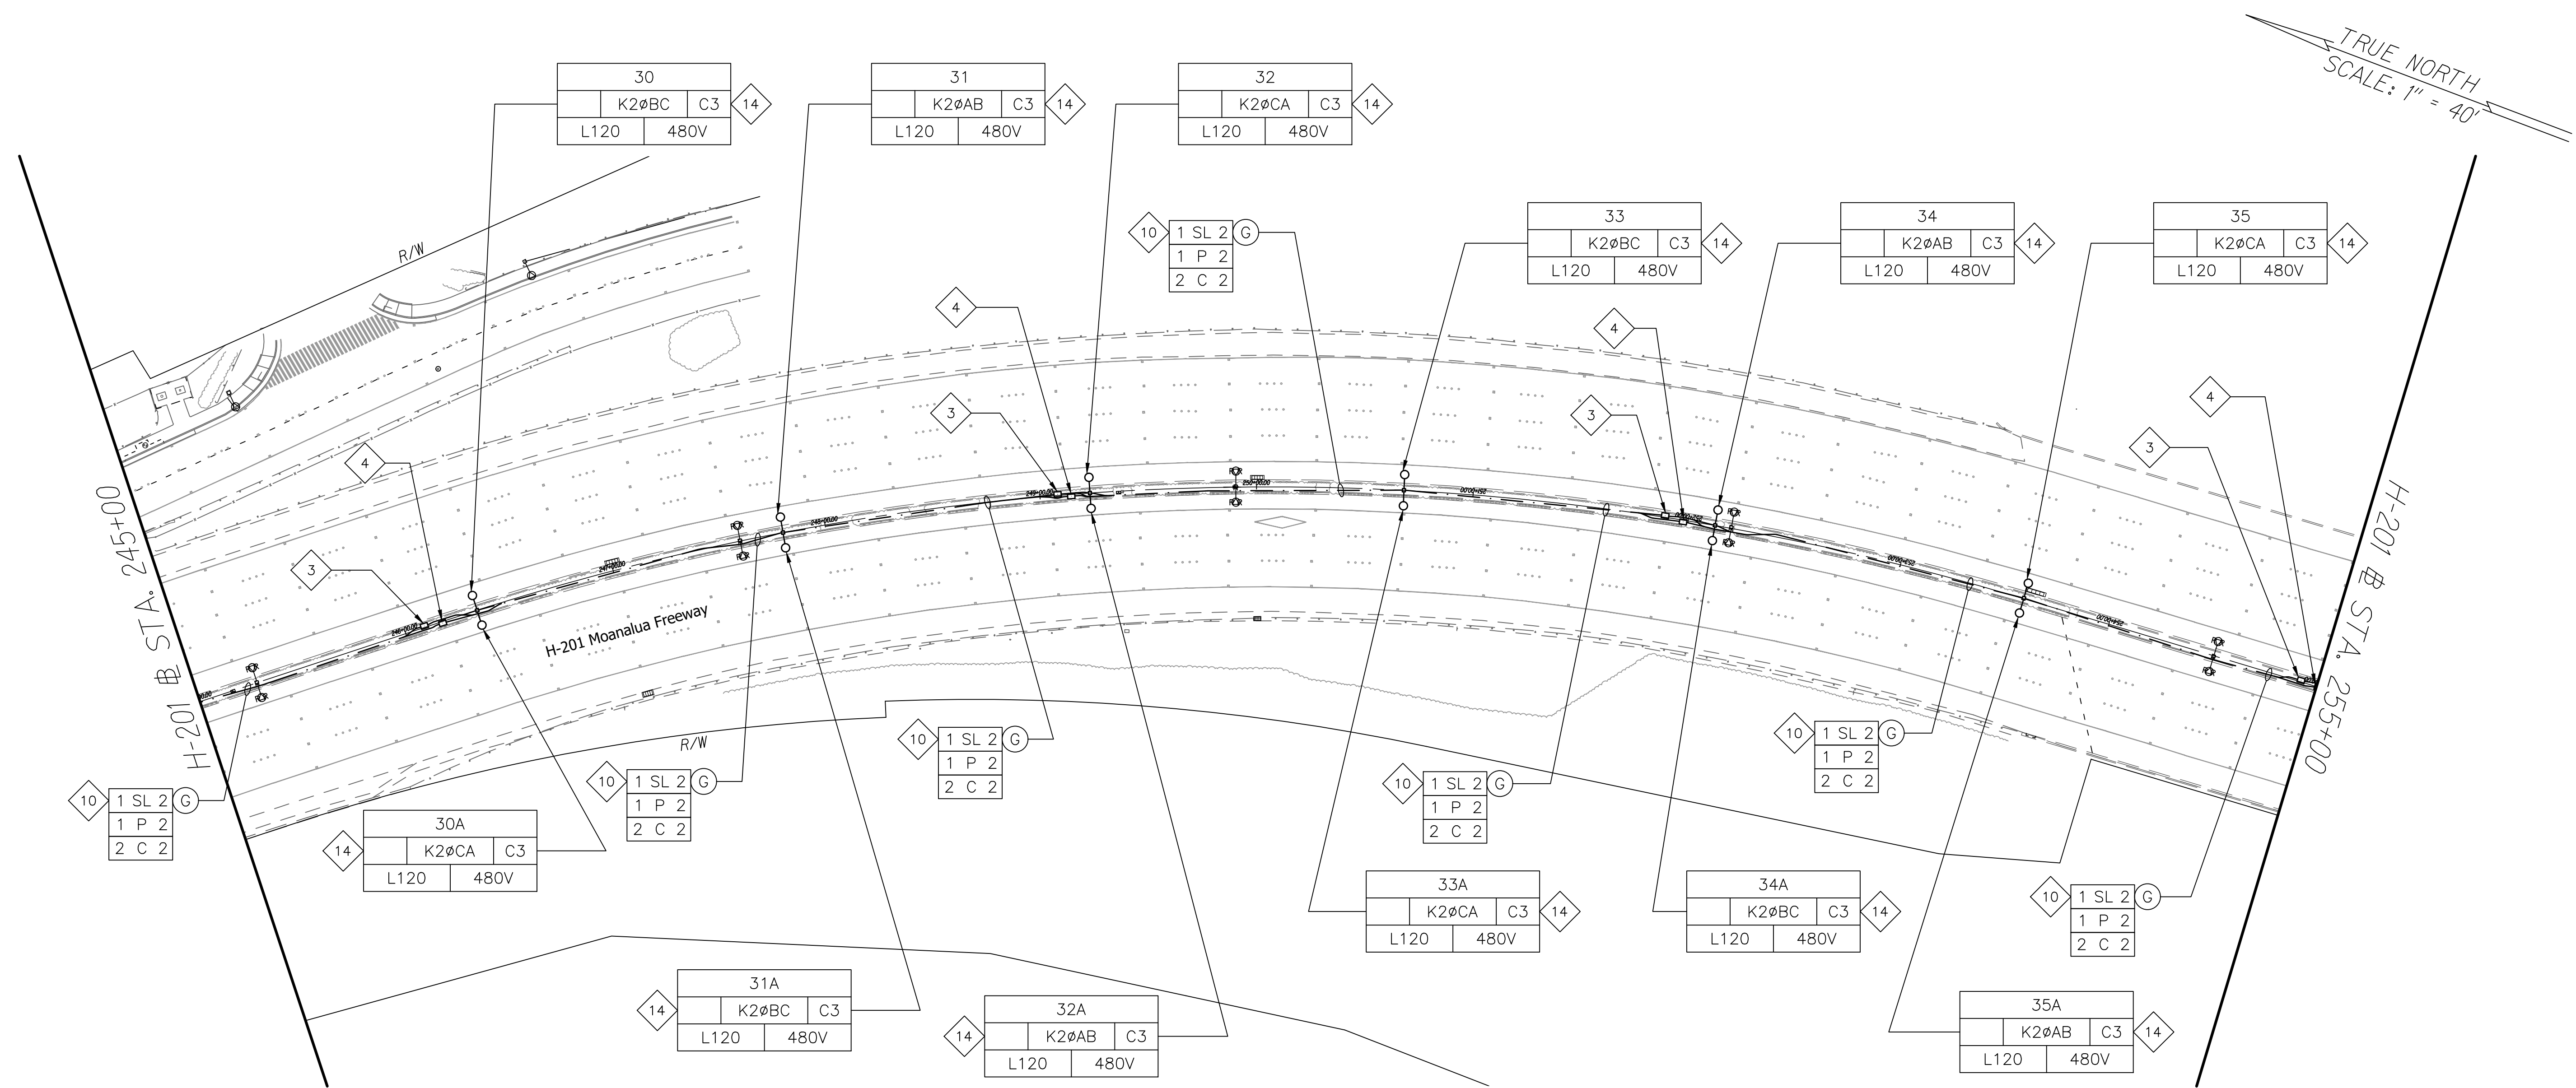


ORIGINAL PLAN	SURVEY PLOTTED BY	DATE
	DRAWN BY	
	DESIGNED BY	
	CHECKED BY	
NOTE BOOK	QUANTITIES BY	
	CHECKED BY	
No.		

H-201 LIGHTING PLAN-5 (ADDITIVE ALT. #1)
Scale 1"=40'-0"

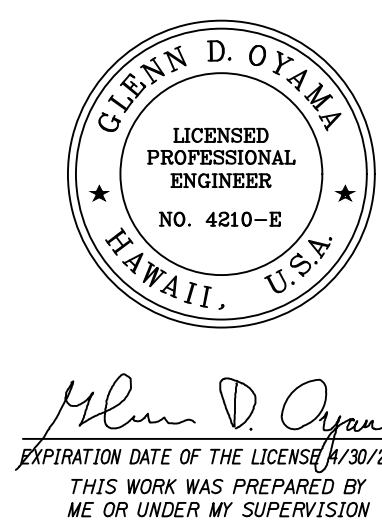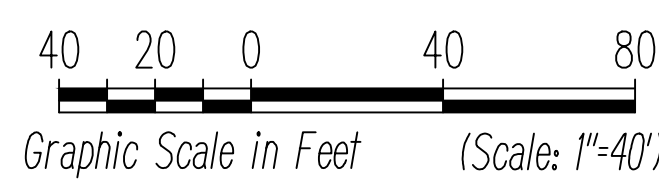

STATE OF HAWAII
DEPARTMENT OF TRANSPORTATION
HIGHWAYS DIVISION
H-201 ADD. ALT. #1 LIGHTING
PLAN STA. 245+00 TO 255+00
MOANALUA FREEWAY, HIGHWAY LIGHTING IMPROVEMENTS
Halawa Heights Off-ramp to Middle St. Overpass
FAP NO. NH-H201(005) PHASE 2
Scale: 1" = 40'-0" Date: July 2020
SHEET No. **E-8** OF 39 SHEETS

FED. ROAD DIST. NO.	STATE	FED. AID PROJ. NO.	FISCAL YEAR	SHEET NO.	TOTAL SHEETS
HAWAII	HAW.	NH-H201(005) Ph2	2020	110	140

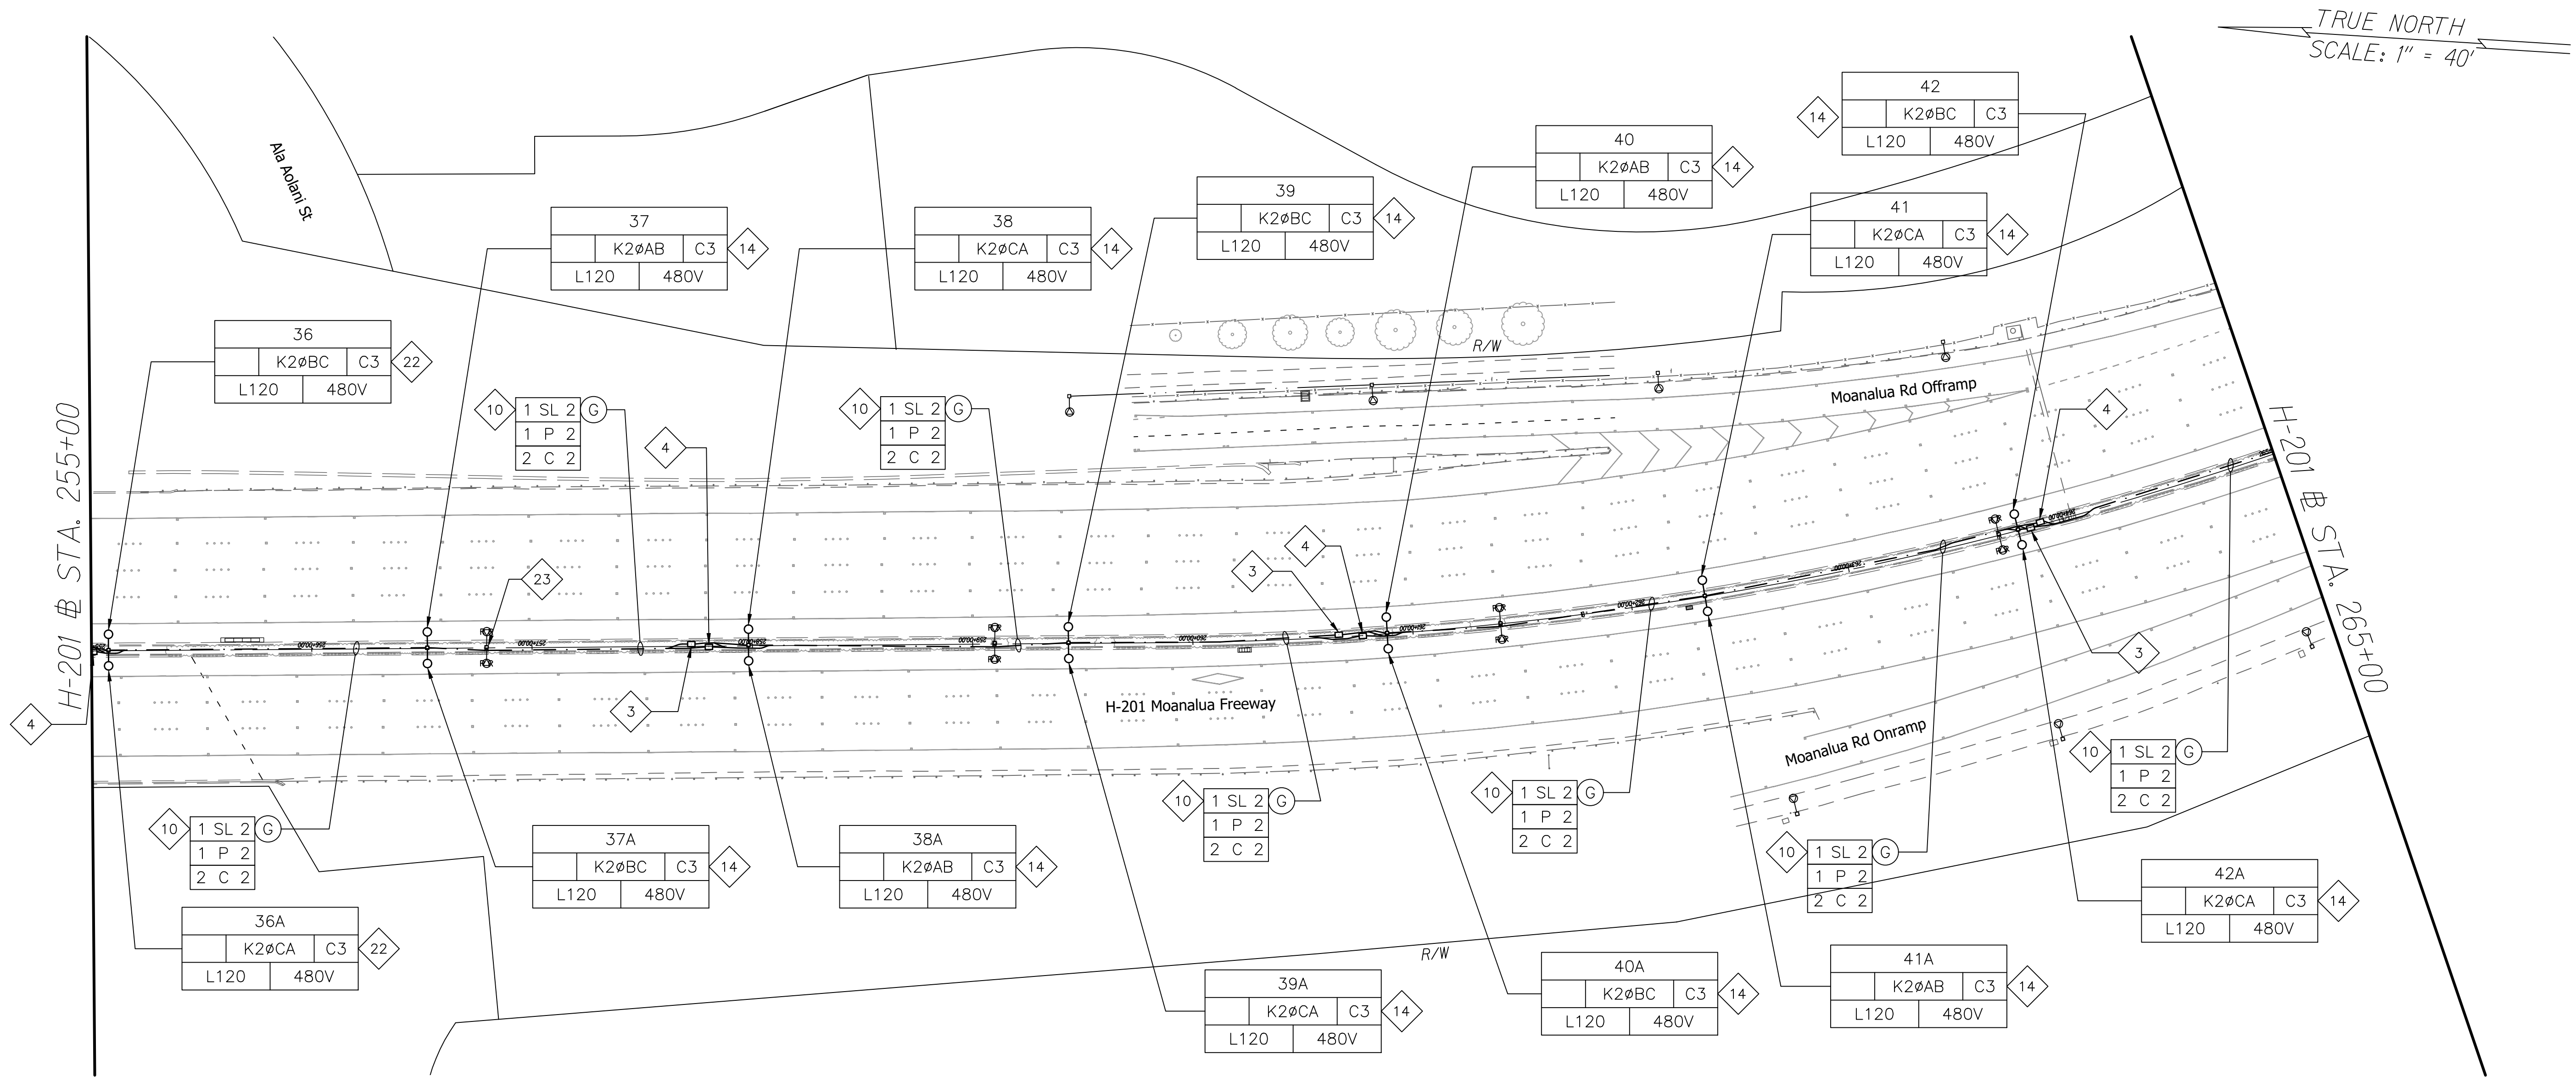

ORIGINAL PLAN	SURVEY PLOTTED BY	DATE
	DRAWN BY	
	DESIGNED BY	
	CHECKED BY	
NOTE BOOK	QUANTITIES BY	
	CHECKED BY	
	No.	

H-201 LIGHTING PLAN-6 (ADDITIVE ALT. #1)
Scale 1"=40'-0"




Glenn D. Oyama
EXPIRATION DATE OF THE LICENSE 11/30/2022
THIS WORK WAS PREPARED BY
ME OR UNDER MY SUPERVISION

STATE OF HAWAII
DEPARTMENT OF TRANSPORTATION
HIGHWAYS DIVISION
H-201 ADD. ALT. #1 LIGHTING
PLAN STA. 255+00 TO 265+00
MOANALUA FREEWAY, HIGHWAY LIGHTING IMPROVEMENTS
Halawa Heights Off-ramp to Middle St. Overpass
FAP NO. NH-H201(005) PHASE 2
Scale: 1" = 40'-0" Date: July 2020
SHEET No. E-9 OF 39 SHEETS



FED. ROAD DIST. NO.	STATE	FED. AID PROJ. NO.	FISCAL YEAR	SHEET NO.	TOTAL SHEETS
HAWAII	HAW.	NH-H201(005) Ph2	2020	111	140

TRUE NORTH
SCALE: 1" = 40'

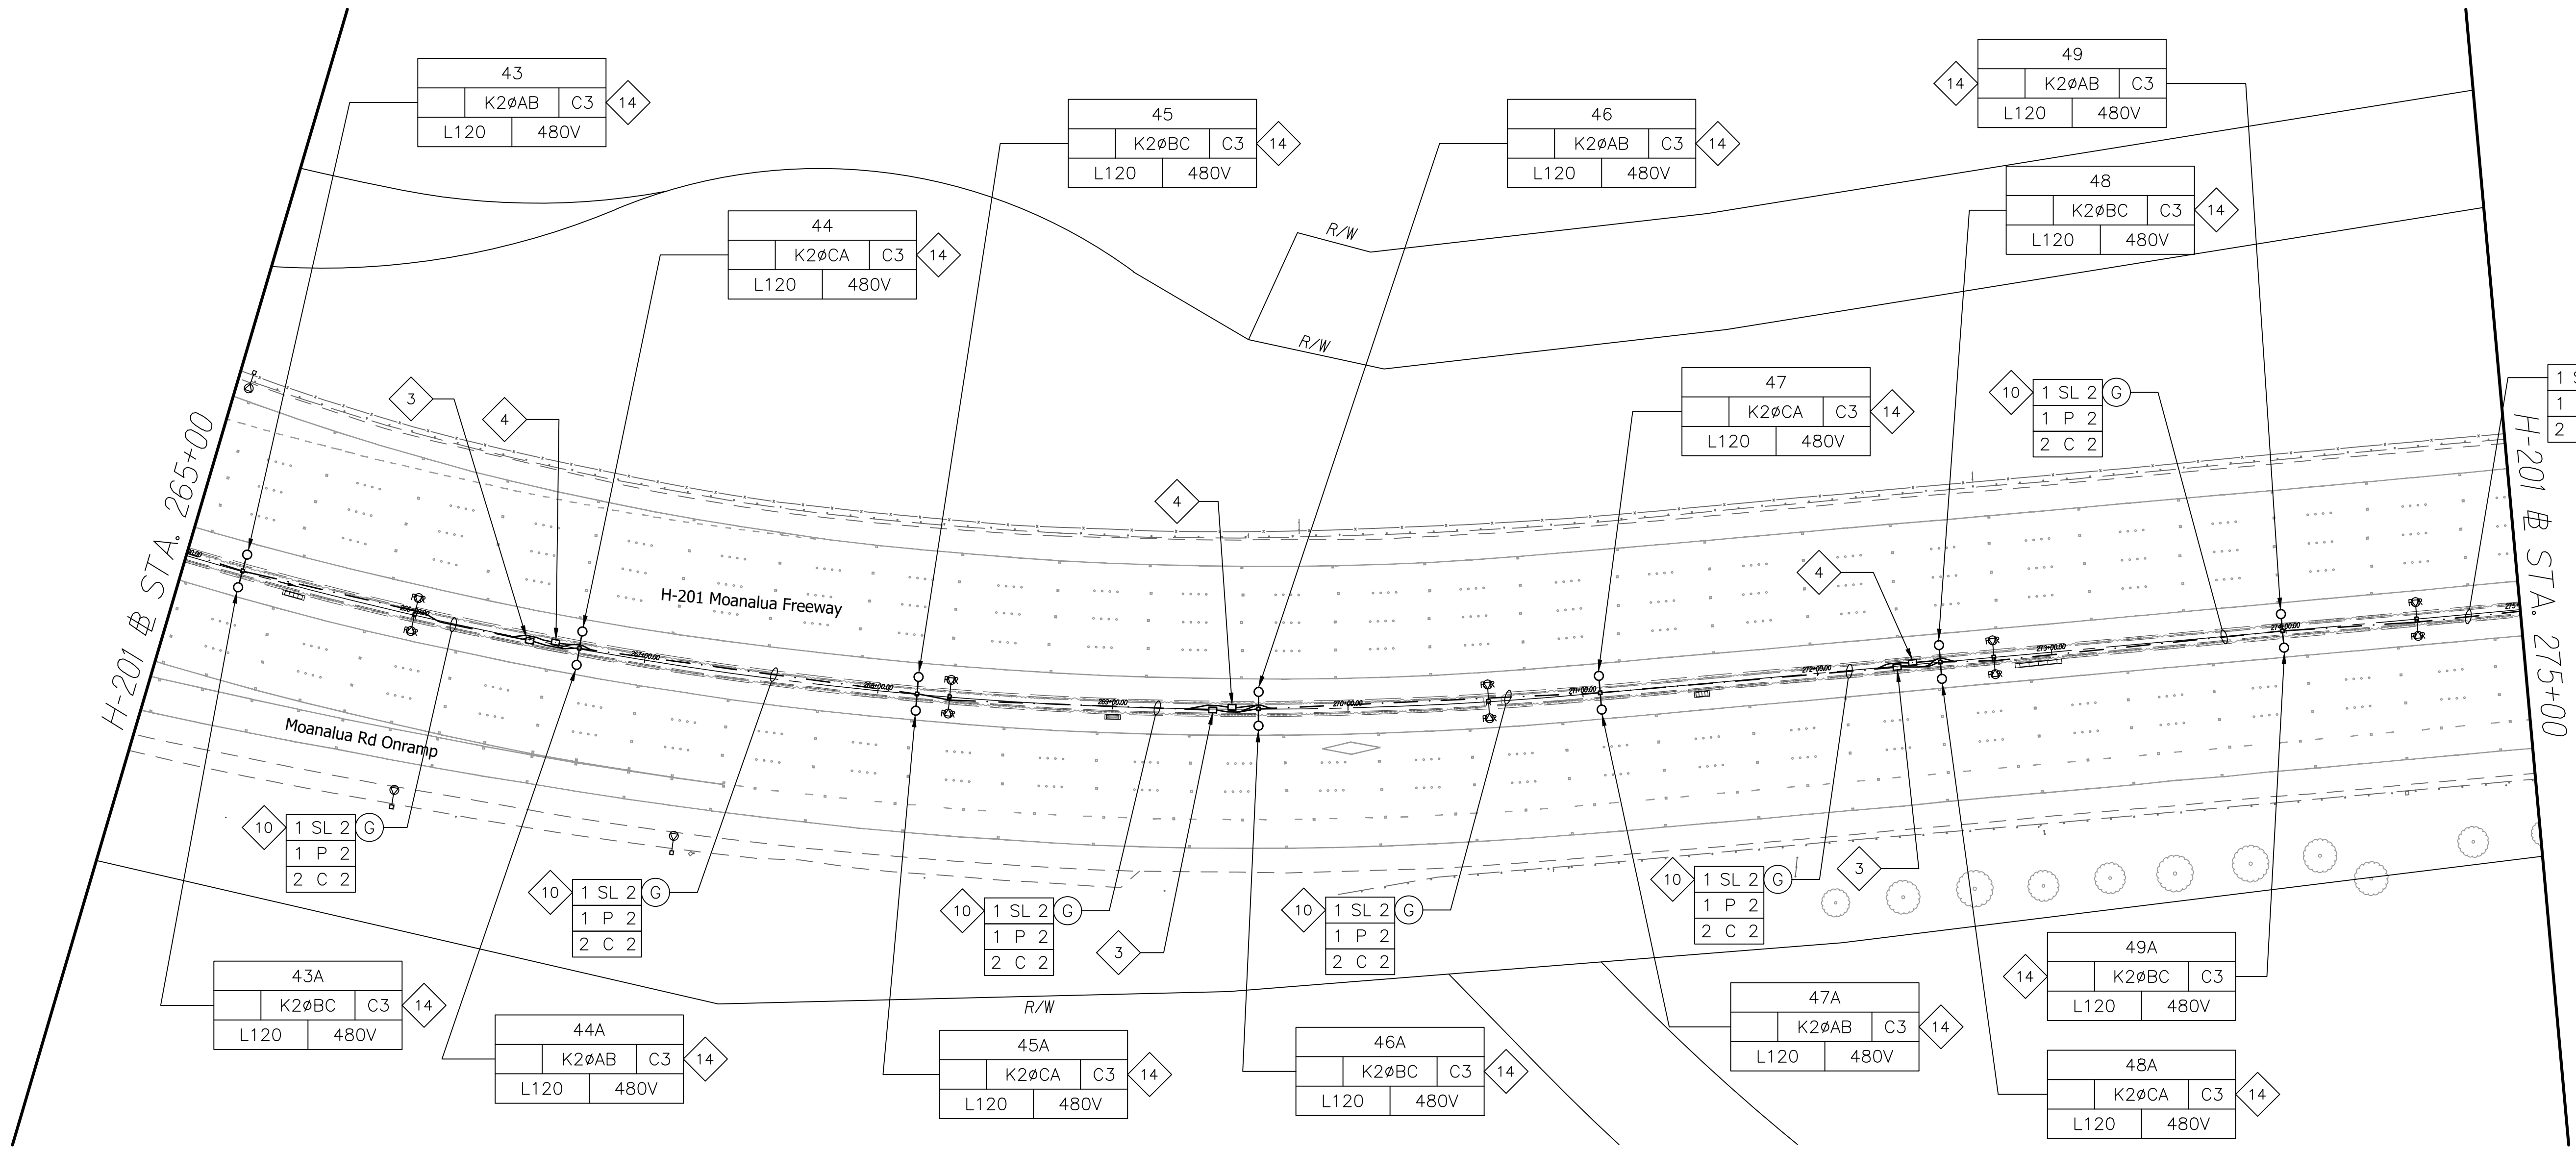

ORIGINAL PLAN	SURVEY PLOTTED BY	DATE
NOTE BOOK	DESIGNED BY	
	QUANTITIES BY	
	CHECKED BY	


H-201 LIGHTING PLAN-7 (ADDITIVE ALT. #1)
Scale 1"=40'-0"

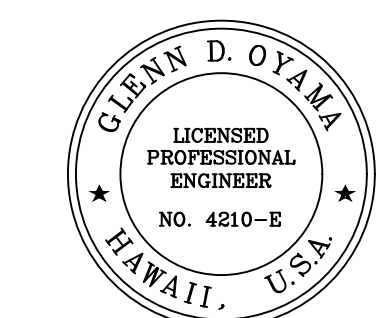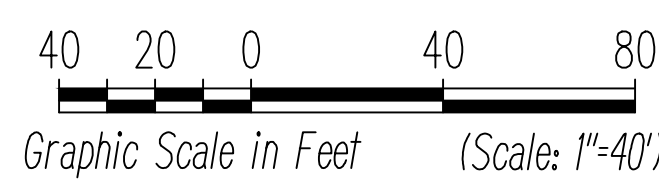

Glenn D. Oyama
EXPIRATION DATE OF THE LICENSE: 11/30/2022
THIS WORK WAS PREPARED BY ME OR UNDER MY SUPERVISION

STATE OF HAWAII
DEPARTMENT OF TRANSPORTATION
HIGHWAYS DIVISION
H-201 ADD. ALT. #1 LIGHTING
PLAN STA. 265+00 TO 275+00
MOANALUA FREEWAY, HIGHWAY LIGHTING IMPROVEMENTS
Halawa Heights Off-ramp to Middle St. Overpass
FAP NO. NH-H201(005) PHASE 2
Scale: 1" = 40'-0" Date: July 2020
SHEET No. E-10 OF 39 SHEETS

FED. ROAD DIST. NO.	STATE	FED. AID PROJ. NO.	FISCAL YEAR	SHEET NO.	TOTAL SHEETS
HAWAII	HAW.	NH-H201(005) Ph2	2020	112	140

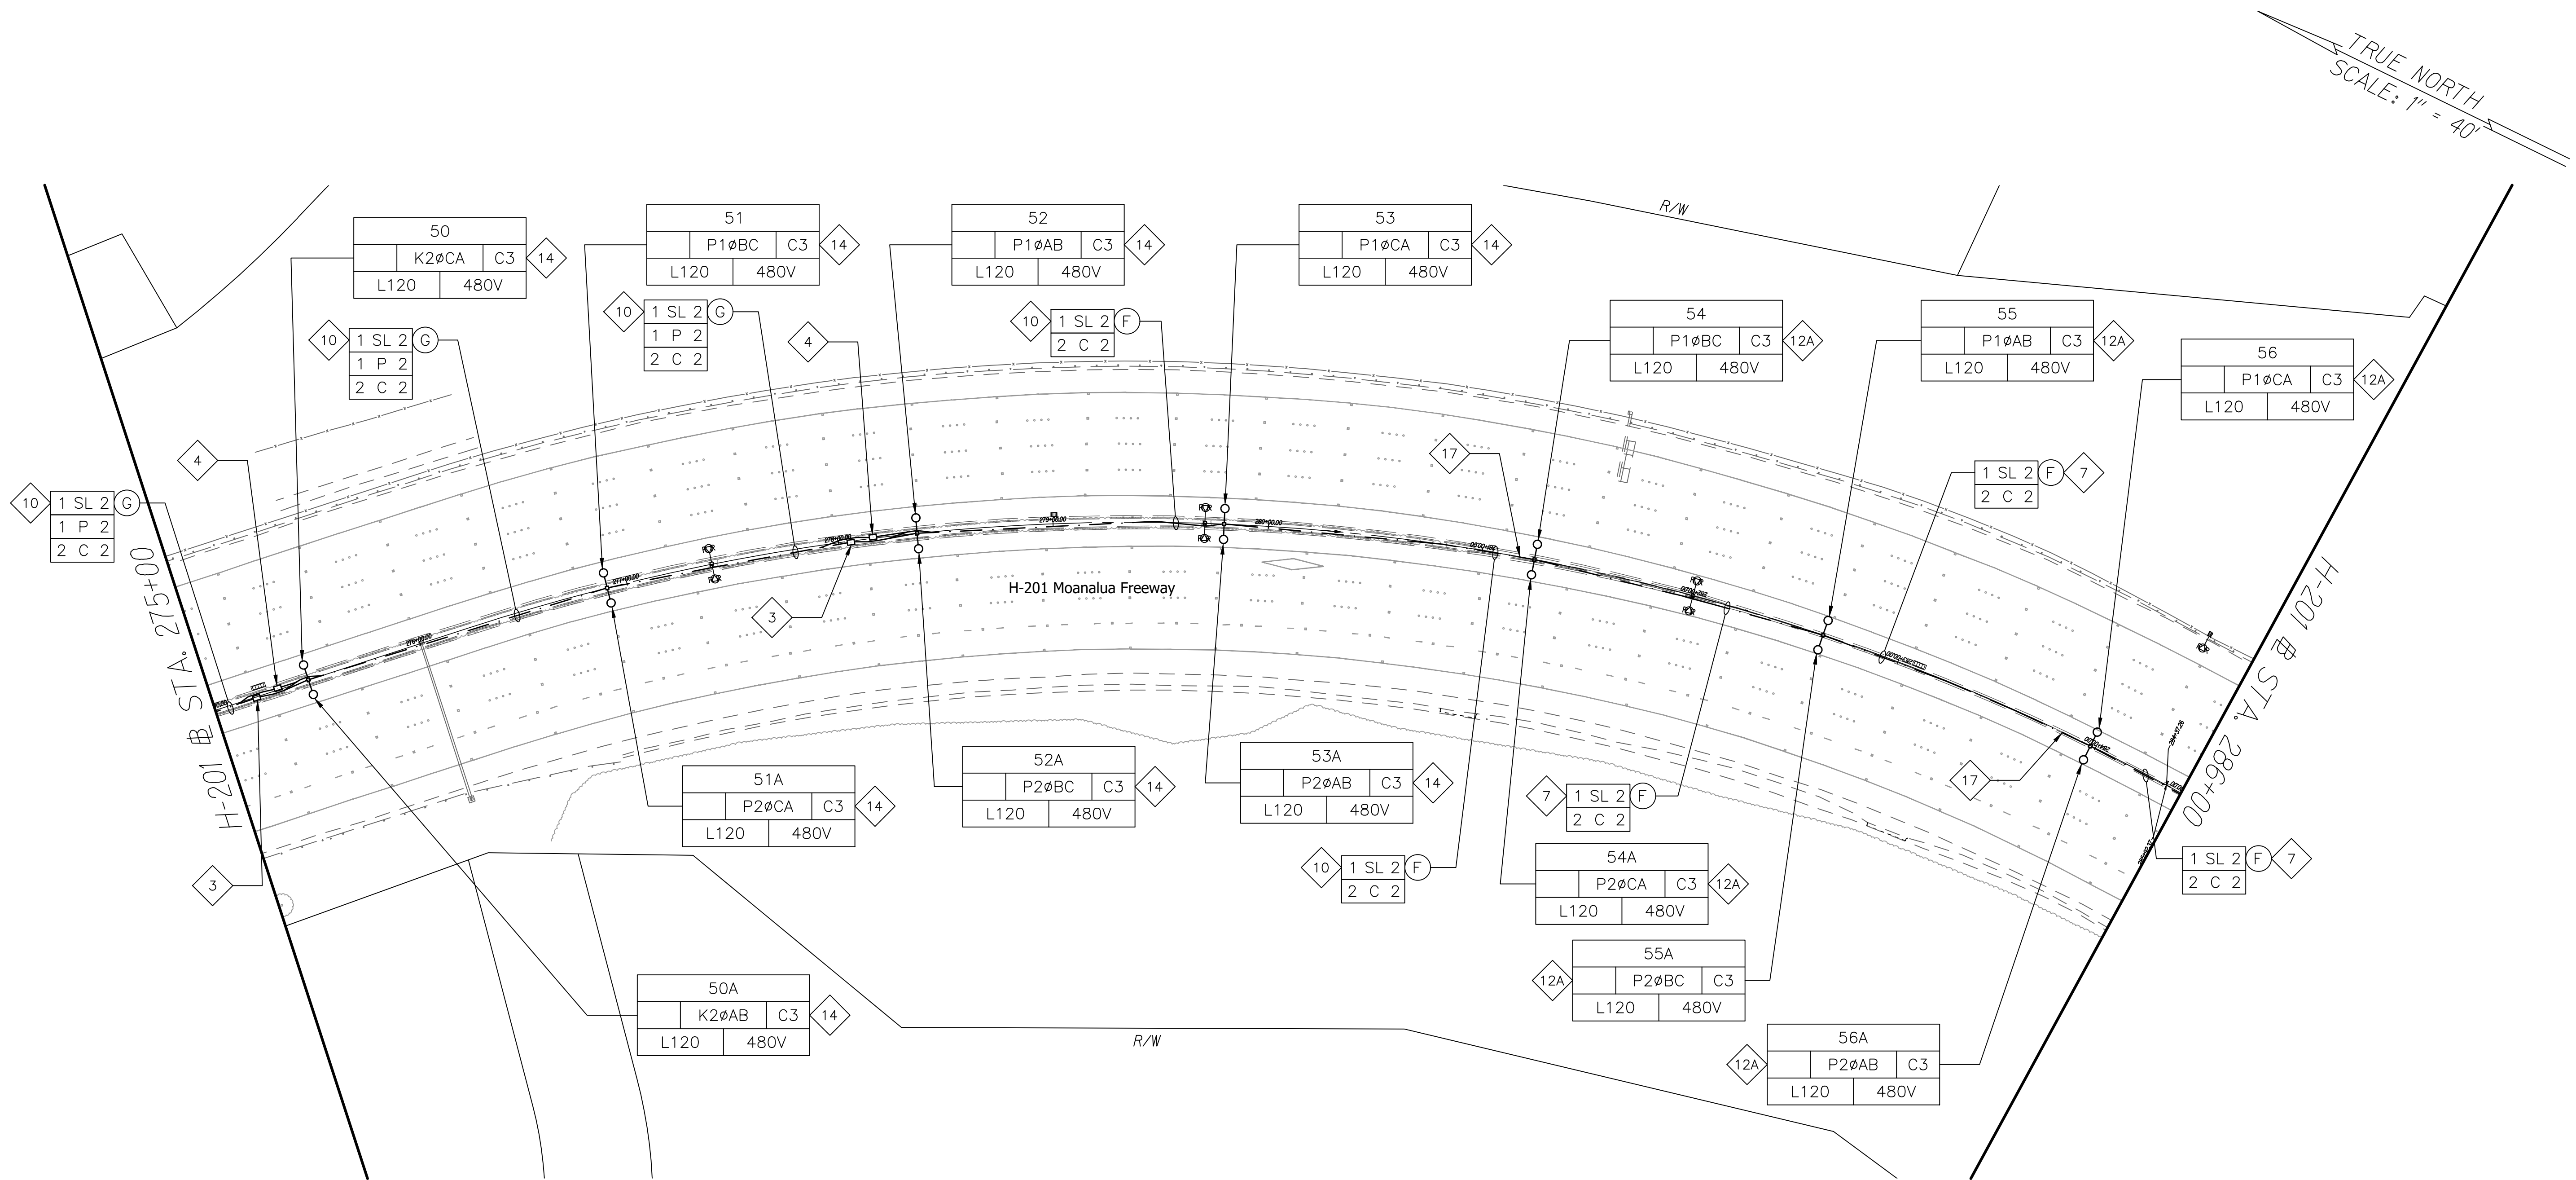

ORIGINAL PLAN	SURVEY PLOTTED BY	DATE
	DRAWN BY	
	DESIGNED BY	
	CHECKED BY	
NOTE BOOK	QUANTITIES BY	
	CHECKED BY	
	No.	

H-201 LIGHTING PLAN-8 (ADDITIVE ALT. #1)
Scale 1"=40'-0"




GLENN D. OYAMA
LICENSED PROFESSIONAL ENGINEER
NO. 4210-E
HAWAII, U.S.A.

Glenn D. Oyama
THIS WORK WAS PREPARED BY
ME OR UNDER MY SUPERVISION



STATE OF HAWAII
DEPARTMENT OF TRANSPORTATION
HIGHWAYS DIVISION
H-201 ADD. ALT. #1 LIGHTING
PLAN STA. 275+00 TO 286+00
MOANALUA FREEWAY, HIGHWAY LIGHTING IMPROVEMENTS
Halawa Heights Off-ramp to Middle St. Overpass
FAP NO. NH-H201(005) PHASE 2
Scale: 1" = 40'-0" Date: July 2020
SHEET No. E-11 OF 39 SHEETS

FED. ROAD DIST. NO.	STATE	FED. AID PROJ. NO.	FISCAL YEAR	SHEET NO.	TOTAL SHEETS
HAWAII	HAW.	NH-H201(005) Ph2	2020	113	140

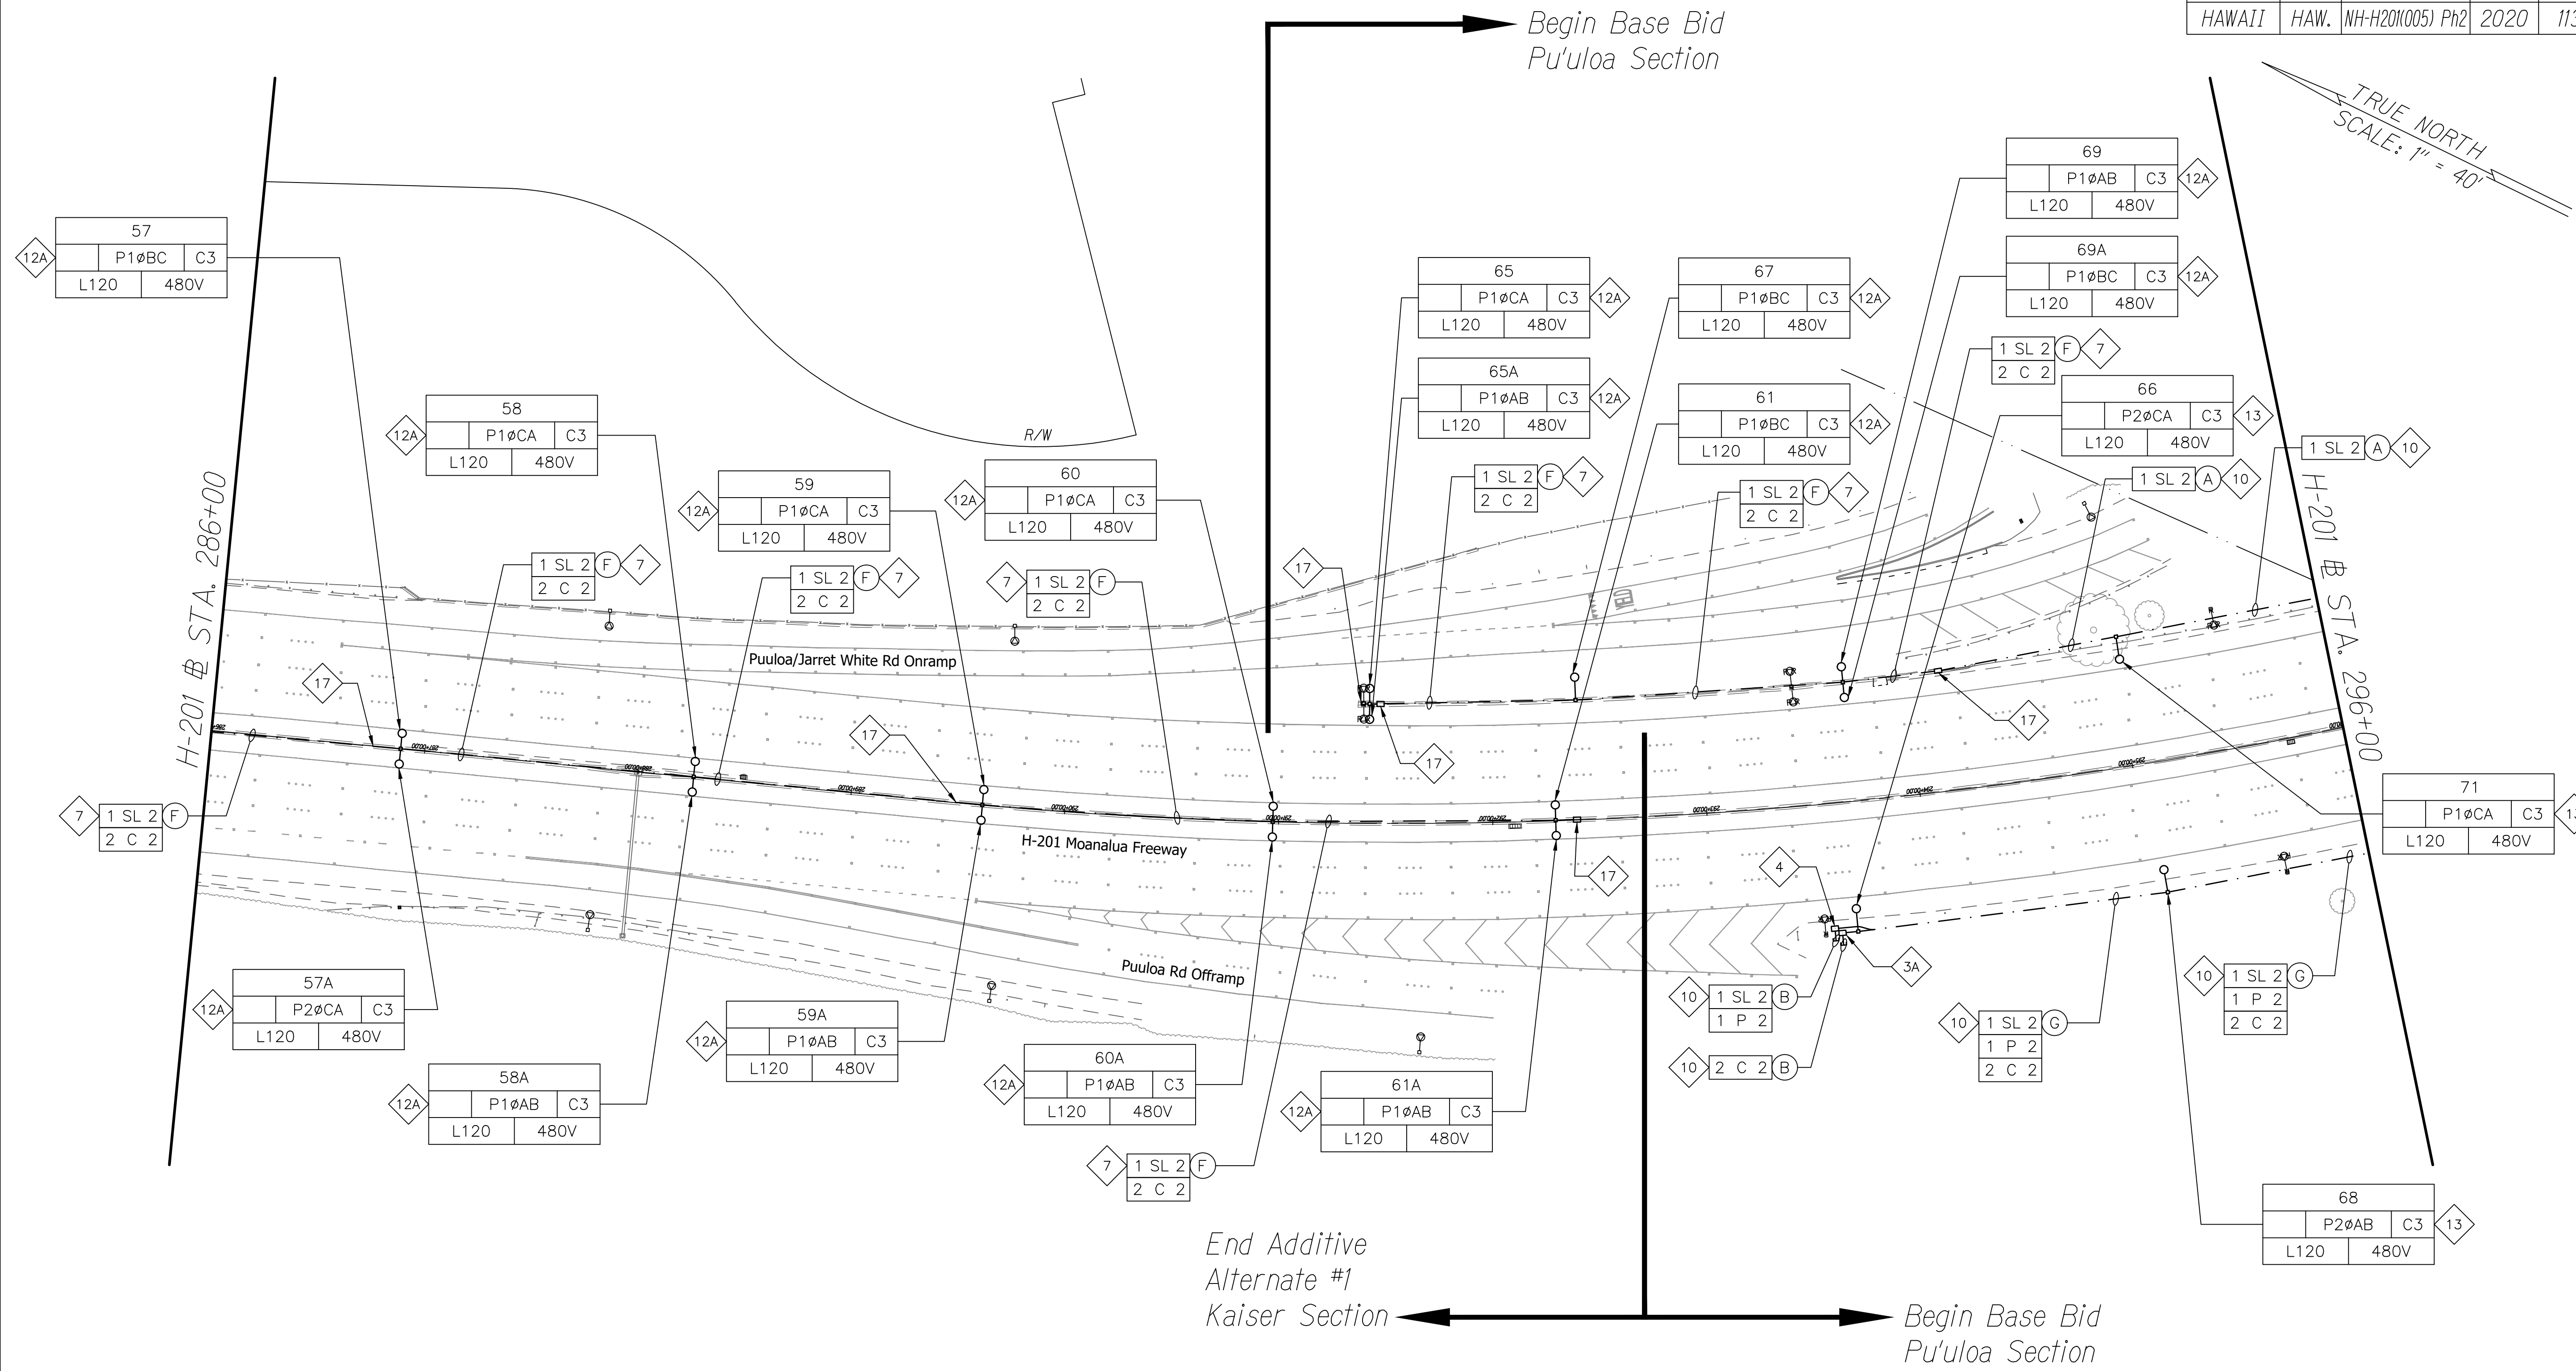


ORIGINAL PLAN	SURVEY PLOTTED BY	DATE
NOTE BOOK	DRAWN BY	
No.	DESIGNED BY	
	QUANTITIES BY	
	CHECKED BY	

H-201 LIGHTING PLAN-9
Scale 1"=40'-0"

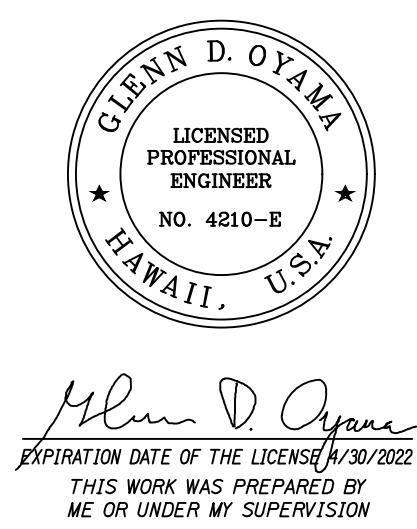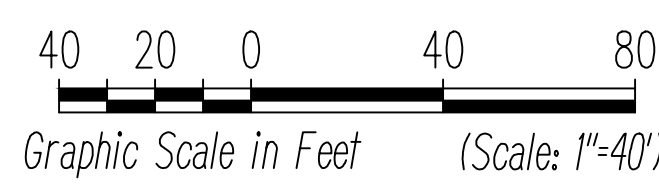



STATE OF HAWAII
DEPARTMENT OF TRANSPORTATION
HIGHWAYS DIVISION
H-201 LIGHTING PLAN
STA. 286+00 TO 296+00
MOANALUA FREEWAY, HIGHWAY LIGHTING IMPROVEMENTS
Halawa Heights Off-ramp to Middle St. Overpass
FAP NO. NH-H201(005) PHASE 2
Scale: 1" = 40'-0" Date: July 2020
SHEET No. E-12 OF 39 SHEETS

FED. ROAD DIST. NO.	STATE	FED. AID PROJ. NO.	FISCAL YEAR	SHEET NO.	TOTAL SHEETS
HAWAII	HAW.	NH-H201(005) Ph2	2020	116	140

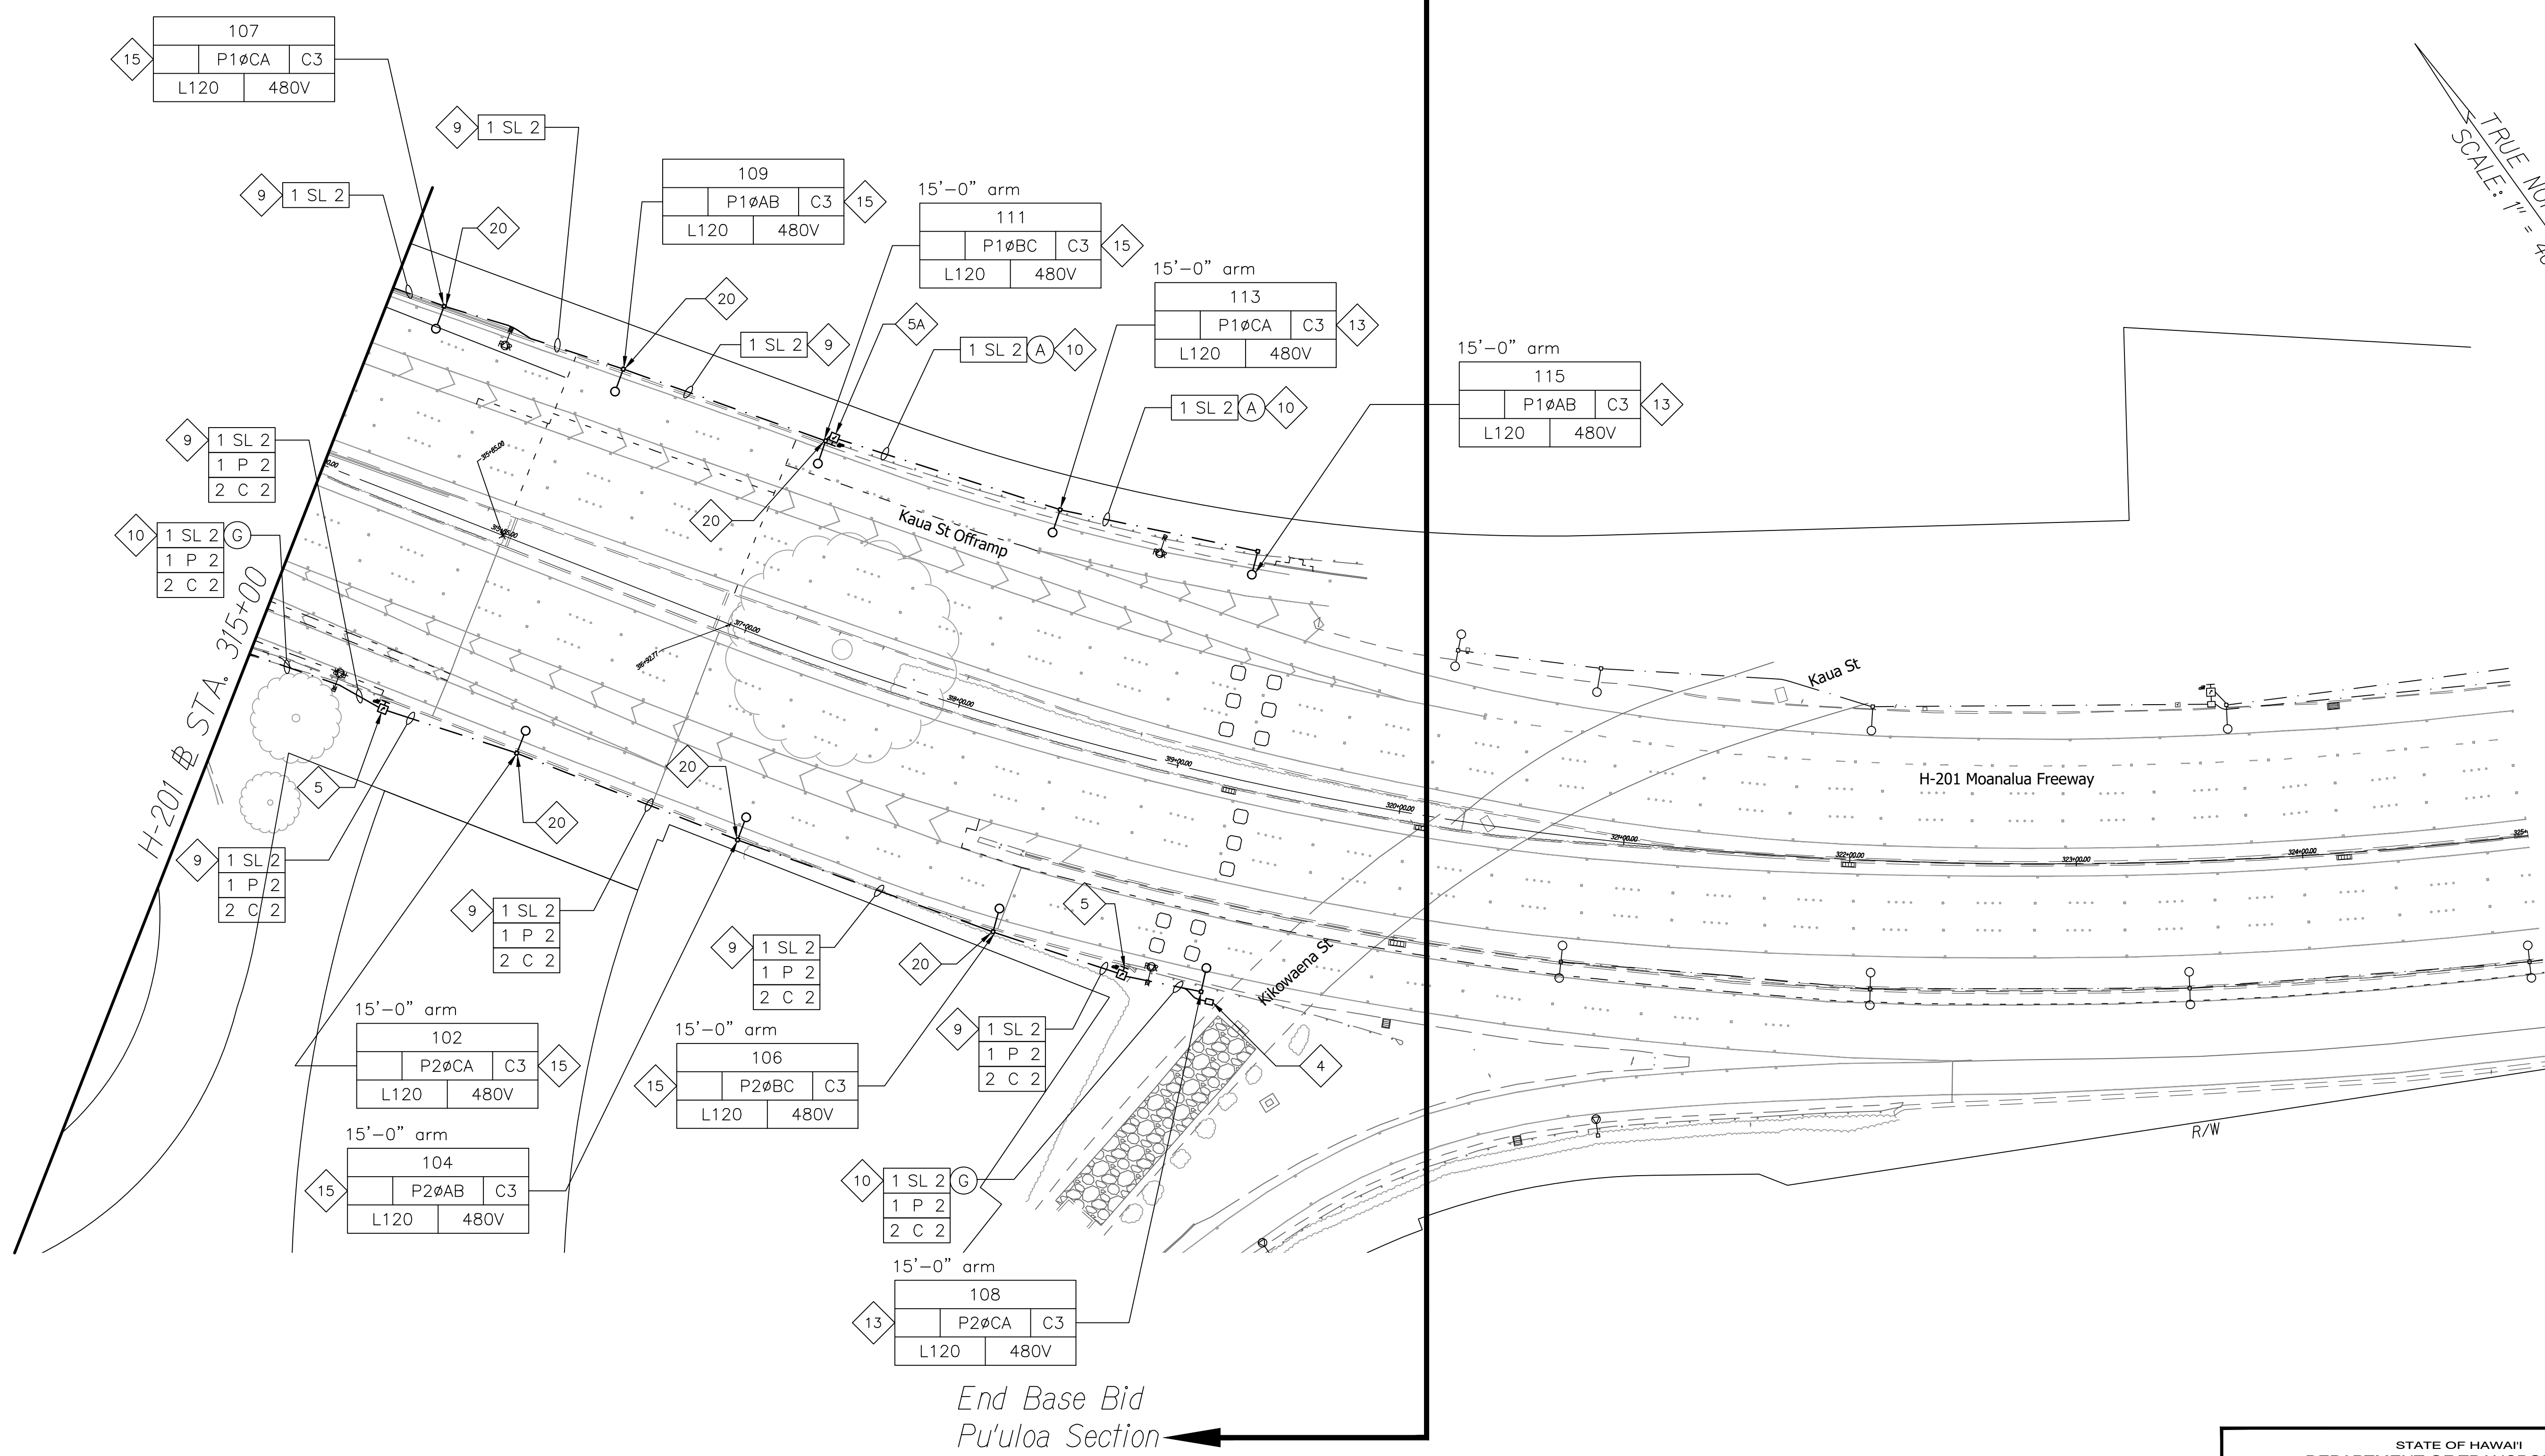

ORIGINAL PLAN	SURVEY PLOTTED BY	DATE
NOTE BOOK	DESIGNED BY	
No.	QUANTITIES BY	
	CHECKED BY	

H-201 LIGHTING PLAN-12
Scale 1"=40'-0"

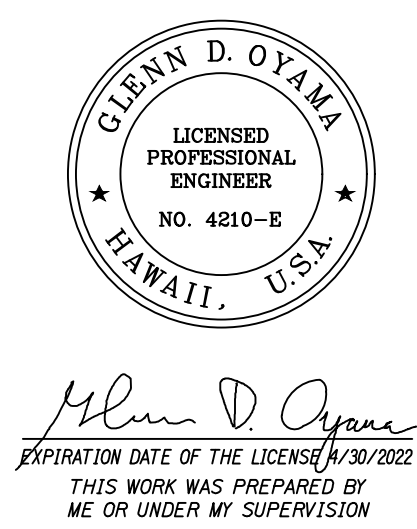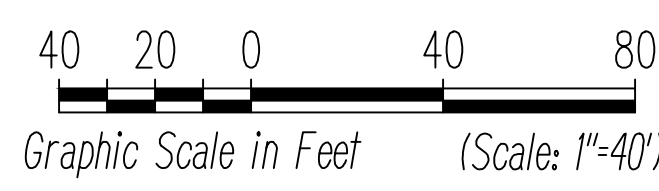

STATE OF HAWAII
DEPARTMENT OF TRANSPORTATION
HIGHWAYS DIVISION
H-201 LIGHTING PLAN
STA. 315+00 TO 325+00
MOANALUA FREEWAY, HIGHWAY LIGHTING IMPROVEMENTS
Halawa Heights Off-ramp to Middle St. Overpass
FAP NO. NH-H201(005) PHASE 2
Scale: 1" = 40'-0" Date: July 2020
SHEET No. E-15 OF 39 SHEETS