

INDEX TO DRAWINGS	
SHEET NO.	DESCRIPTION
1	TITLE SHEET
2	STANDARD PLANS SUMMARY
3-4	NOTES AND ABBREVIATIONS
5	GENERAL PLAN
6-7	TYPICAL ROADWAY SECTIONS
8	PROFILE AND SUPERELEVATION DIAGRAM
9	PLAN
10-11	GRADING PLANS
12	SERVICE ROAD PROFILE
13	MISCELLANEOUS DETAILS
14-22	DRAINAGE SUMMARY, PLAN & DETAILS
① 23-26	CROSS SECTIONS
27-34	MSRW PLAN, ELEVATIONS & DETAILS
35-60	BRIDGE PLANS & DETAILS
61-66	BORING LOGS
67-72	ELECTRICAL PLANS & DETAILS
② 73-75	HAIKU OMEGA TRANSMITTER FACILITIES


26S-1, 26S-2 & 26S-3 CROSS SECTIONS
26S-4, 26S-5

TOTAL SHEET COUNT AFTER ADDITION
POSTINGS: ~~78~~ SHEETS
80

PLAN SHT. NOS. ① C.O. 26S-1, C.O. 26S-2, C.O. 26S-3,
C.O. 26S-4, C.O. 26S-5, ② C.O. 75S-1 AND C.O. 75S-2
ARE SUPPLEMENTARY SHEETS TO THIS PROJECT.

TOTAL SHEET COUNT AFTER "AS BUILT" POSTINGS: 82 SHEETS

STATE OF HAWAII
DEPARTMENT OF TRANSPORTATION
HIGHWAYS DIVISION
HONOLULU, HAWAII
"AS - BUILT"
PLANS FOR
CONSTRUCTION OF A PORTION OF
INTERSTATE ROUTE H-3
HAIKU VALLEY BRIDGES
FEDERAL AID PROJECT NO. I-H3-I(52)
DISTRICT OF KOOLAUPOKO
ISLAND OF OAHU

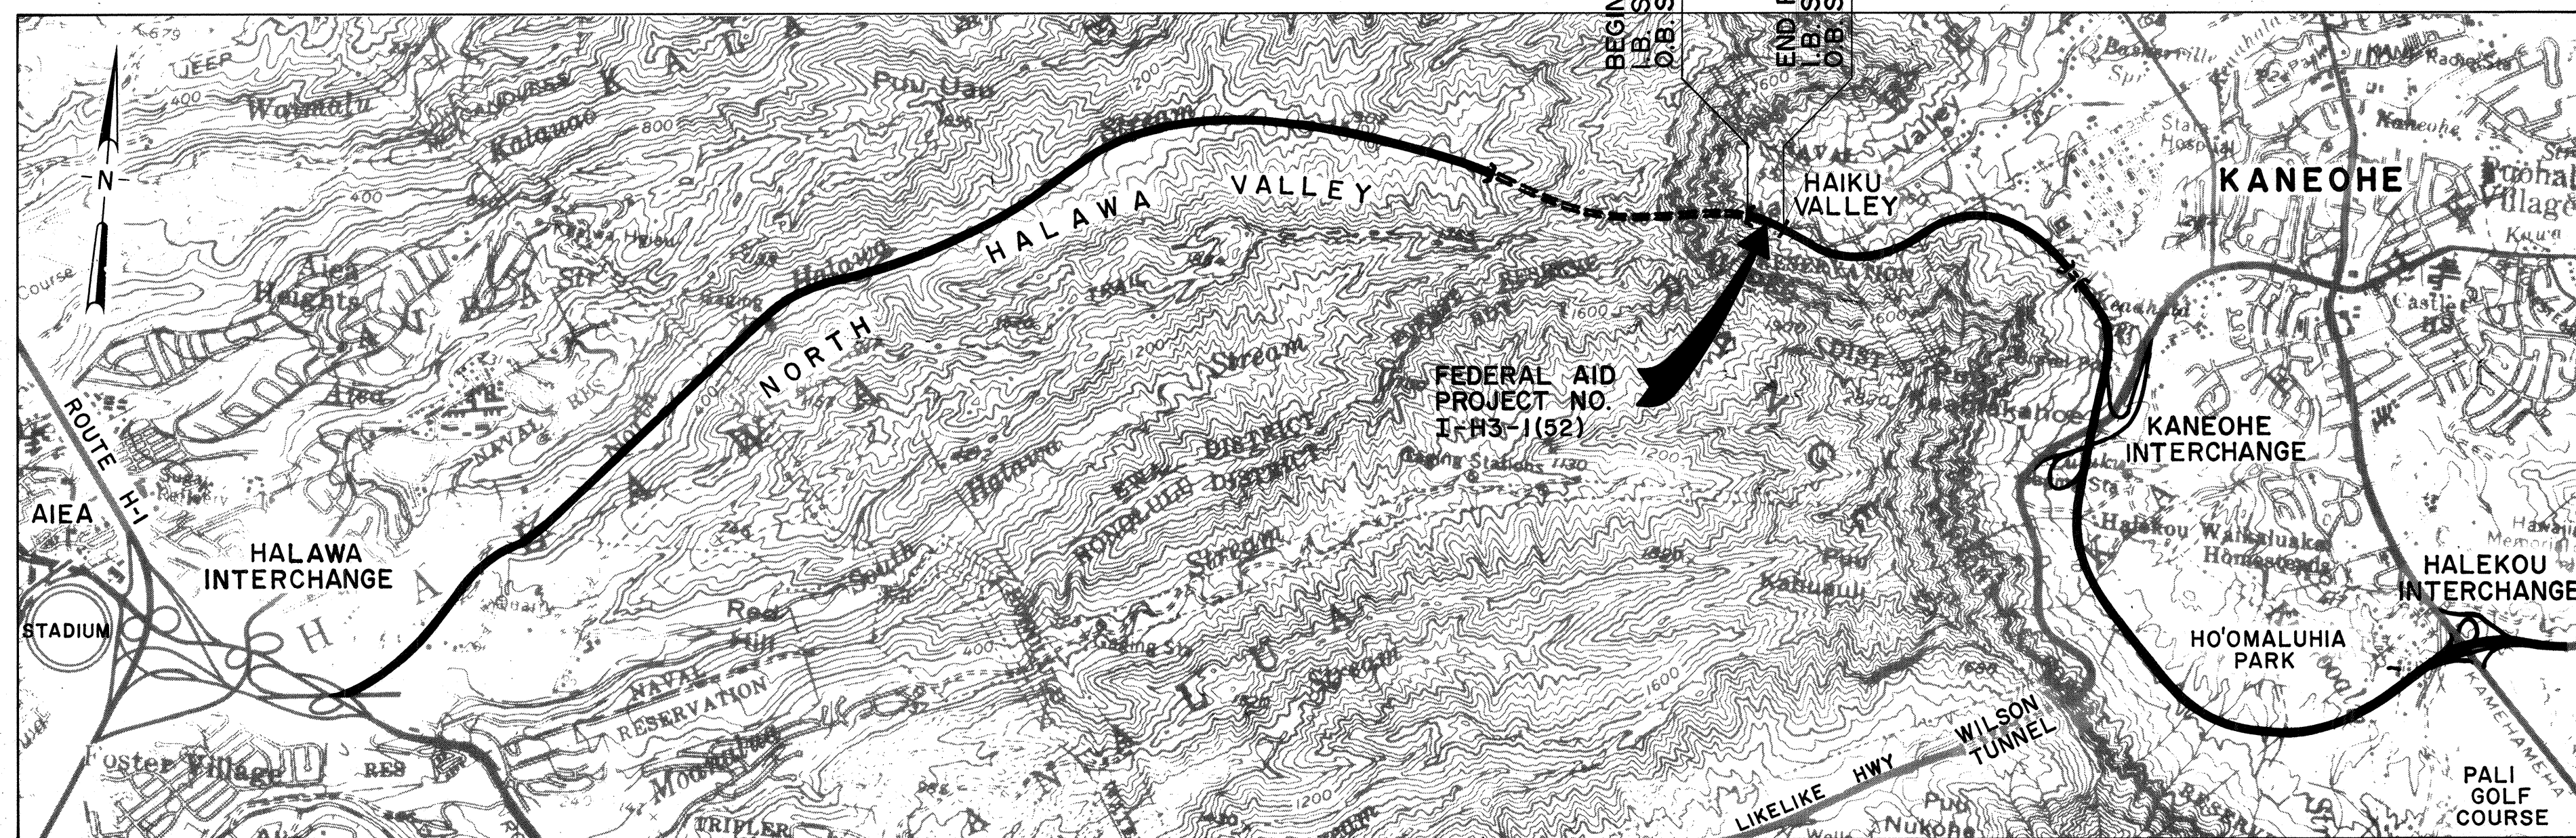


DESIGN CLASSIFICATION

ADT (1998)	39,430
ADT (2008)	45,220
DHV	4,282
D	76/24
T (HOURLY)	2.10 %
T (DAILY)	4.10 %
V	50 MPH

LAYOUT PLAN

GROSS LENGTH OF PROJECT	0.13 MI.
BRIDGES OVER 20.00' SPAN	0.06 MI.
NET LENGTH OF ROADWAY	0.07 MI.

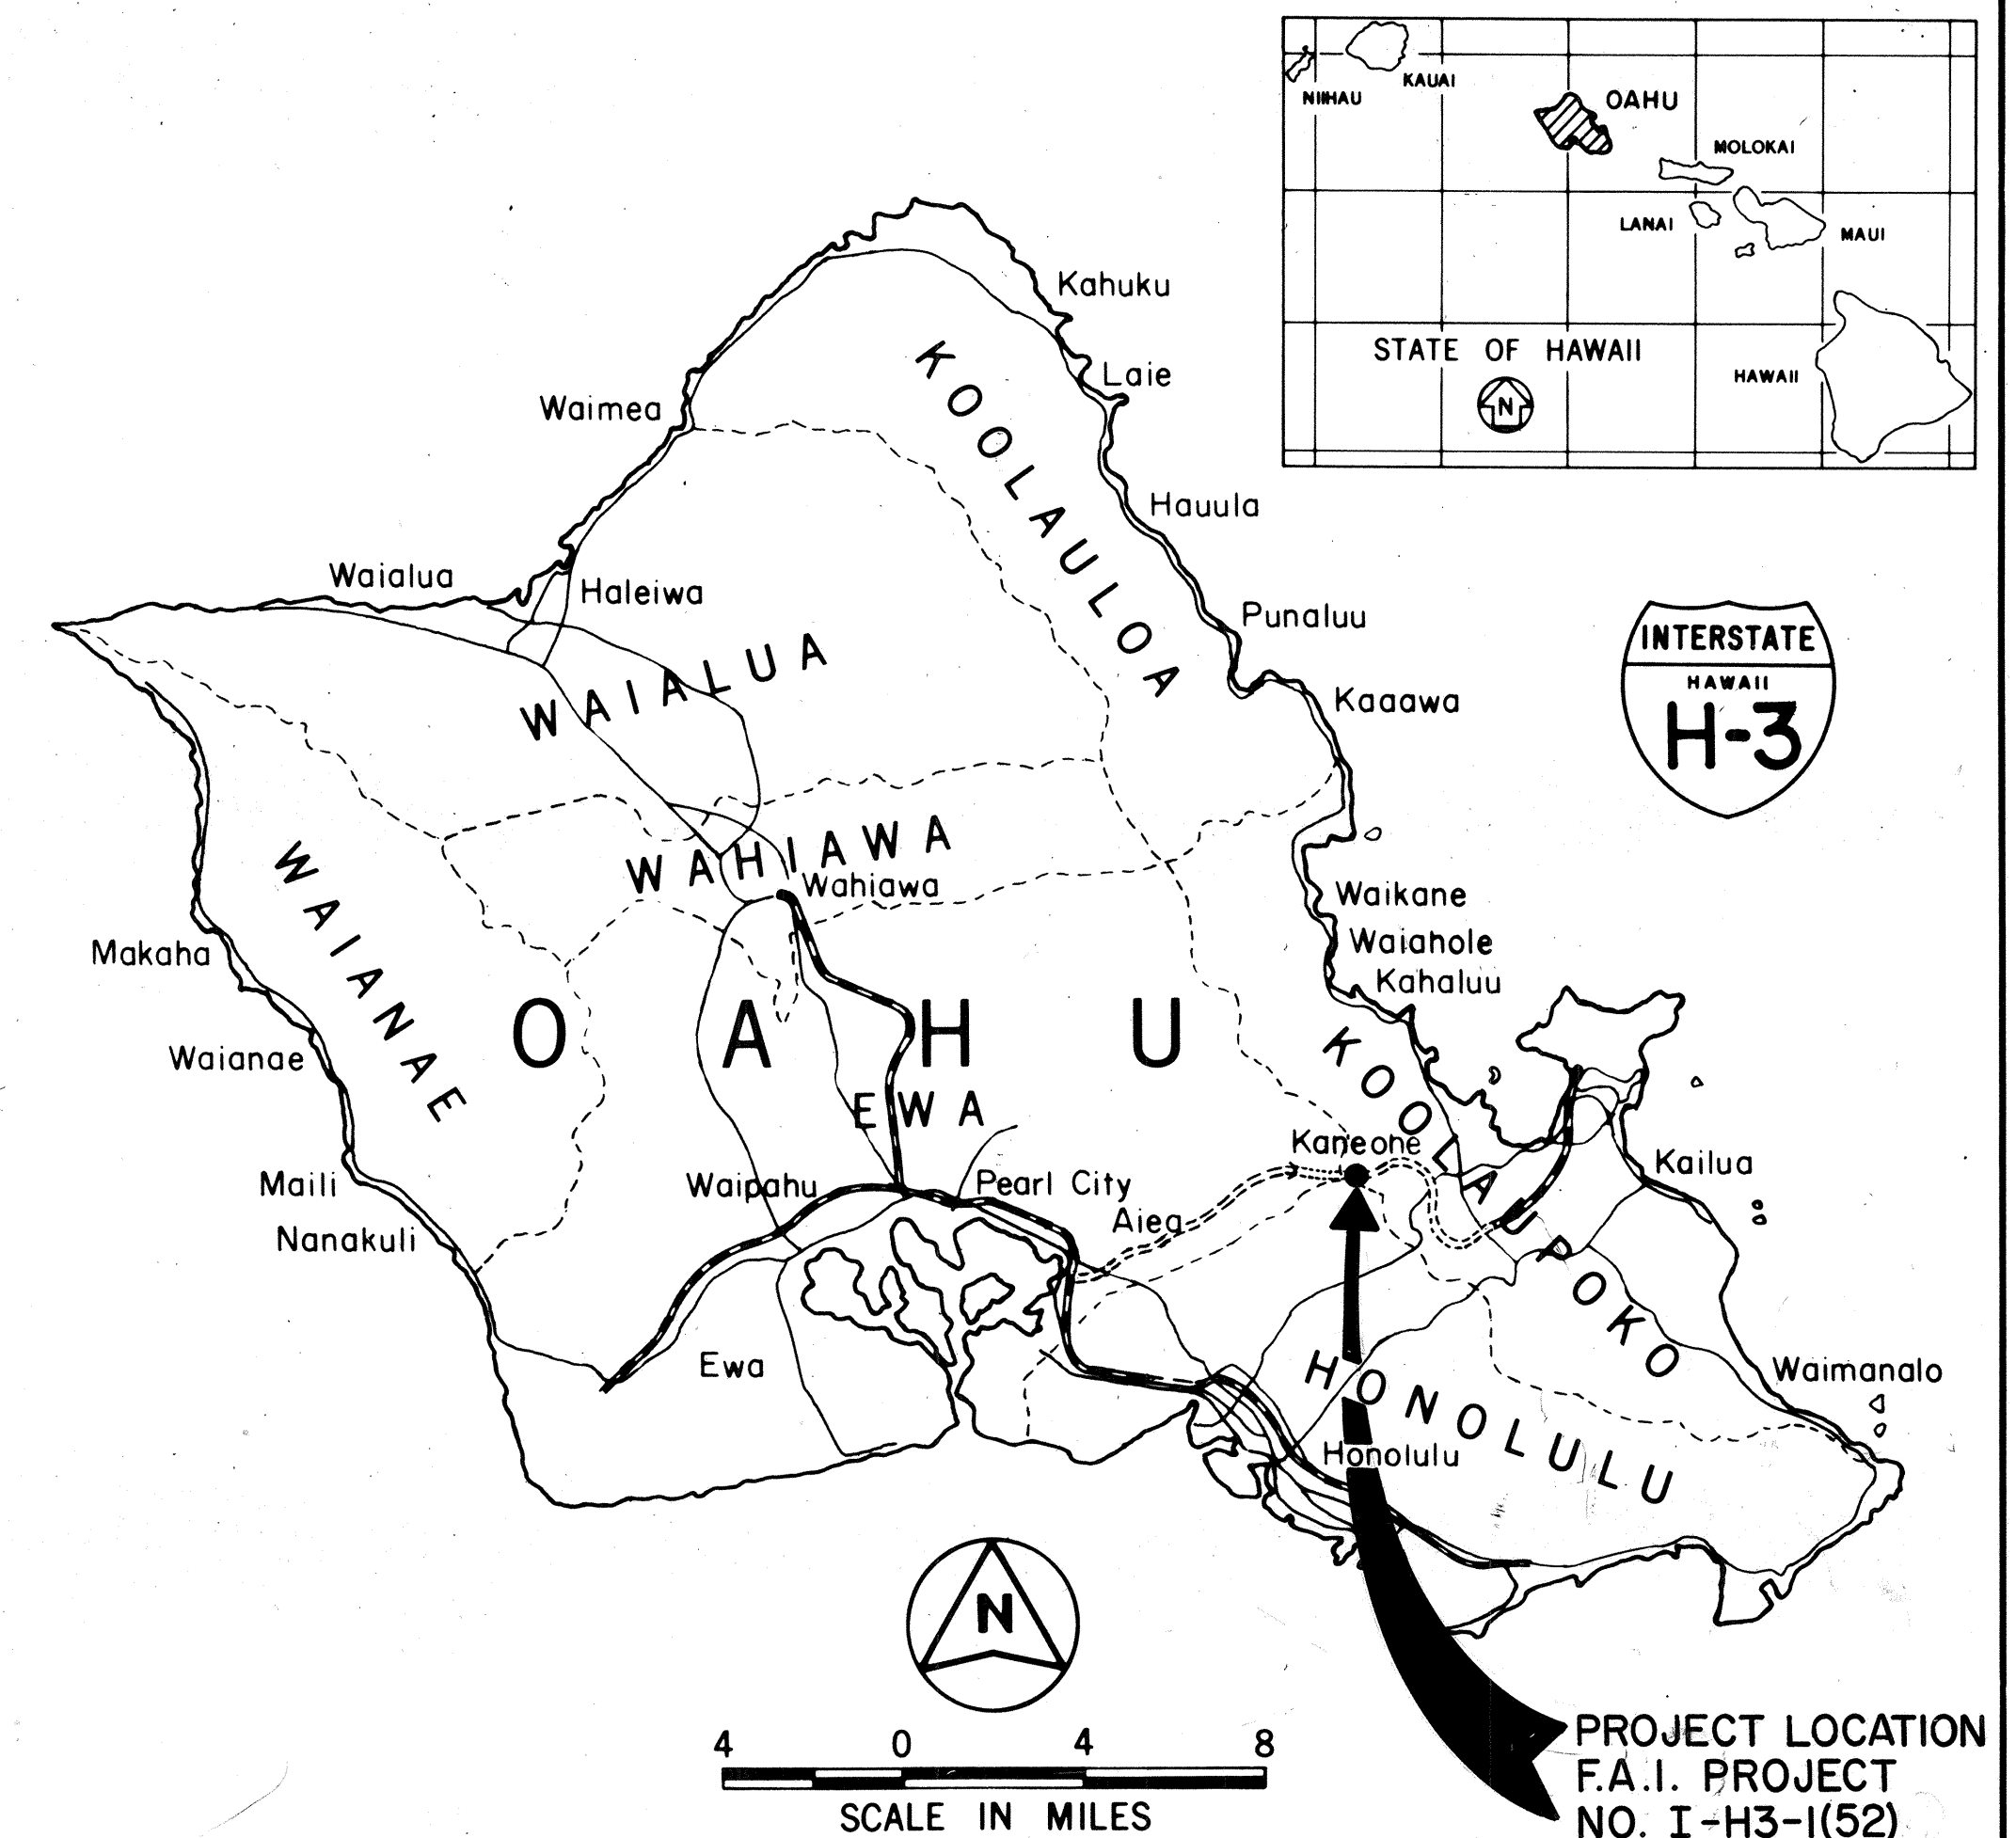

FEDERAL AID INTERSTATE PROJECTS PREVIOUSLY CONSTRUCTED
OR UNDER CONSTRUCTION

CHANGES MADE DURING CONSTRUCTION HAVE BEEN
INCORPORATED ON THESE PLANS EXCEPT CHANGES
IN THE ORIGINAL THEORETICAL QUANTITIES. FOR
ACTUAL QUANTITIES, REFER TO PROJECT LEDGER
AND/OR COMPUTATION BOOK.

for *Ungring* 11/26/01
RESIDENT ENGINEER DATE

DEPARTMENT OF TRANSPORTATION
FEDERAL HIGHWAY ADMINISTRATION
APPROVED:
W. Arthur 11/17/88
DIVISION ADMINISTRATOR DATE

DEPARTMENT OF TRANSPORTATION
STATE OF HAWAII
APPROVED:
Edward H. H. H. 8/13/88
DIR. OF TRANSPORTATION DATE

AS BUILT

CO. ADD. I