
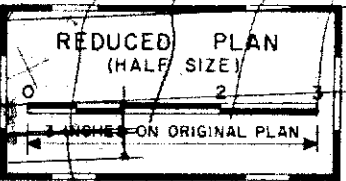


FED. ROAD DIST. NO.	STATE	FED. AID PROJ. NO.	FISCAL YEAR	SHEET NO.	TOTAL SHEETS
HAWAII	HAW.	I-H3-1(54)	1989	6	127


ORIGINAL PLAN	DATE
PLANNED BY	
DESIGNED BY	
NOTED BY	
CHECKED BY	

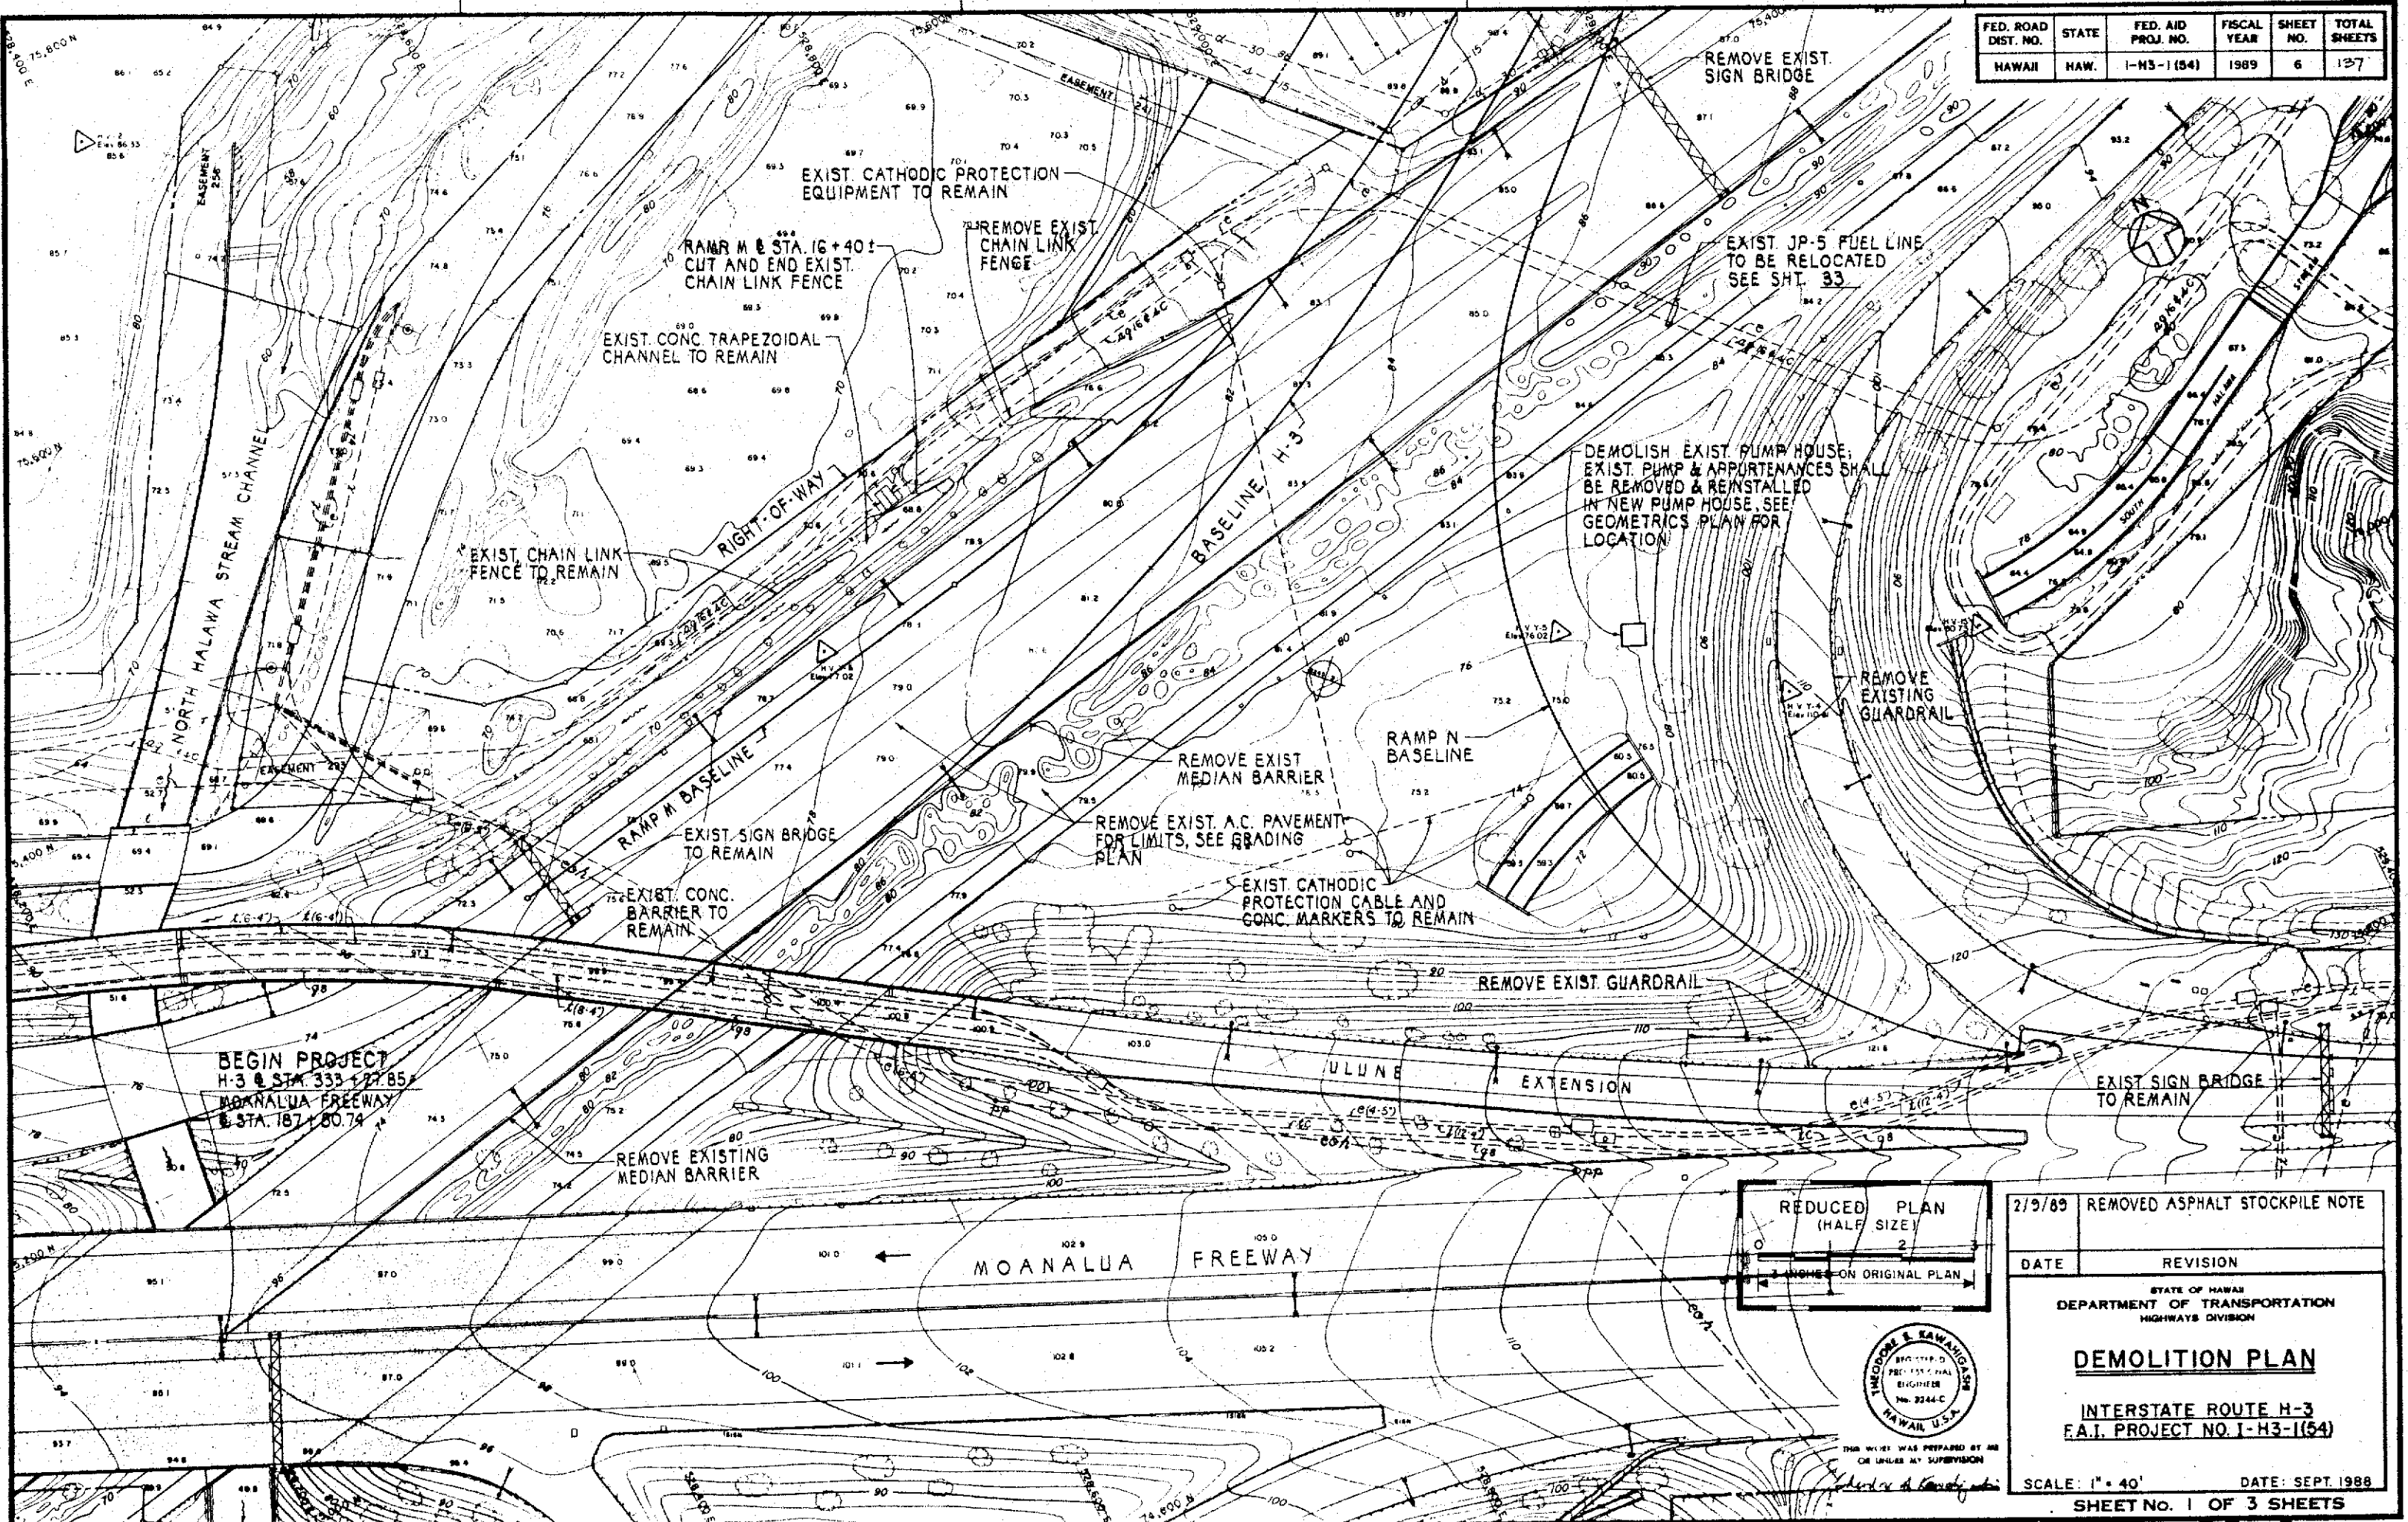

2/9/89	REMOVED ASPHALT STOCKPILE NOTE
DATE	REVISION
STATE OF HAWAII DEPARTMENT OF TRANSPORTATION HIGHWAYS DIVISION	
DEMOLITION PLAN	
INTERSTATE ROUTE H-3 F.A.T. PROJECT NO. I-H3-1(54)	
SCALE: 1" = 40'	DATE: SEPT. 1988
SHEET NO. 1 OF 3 SHEETS	

ADD 6


FED. ROAD DIST. NO.	STATE	FED. AID PROJ. NO.	FISCAL YEAR	SHEET NO.	TOTAL SHEETS
HAWAII	HAW.	I-H3-1(184)	1989	7	127

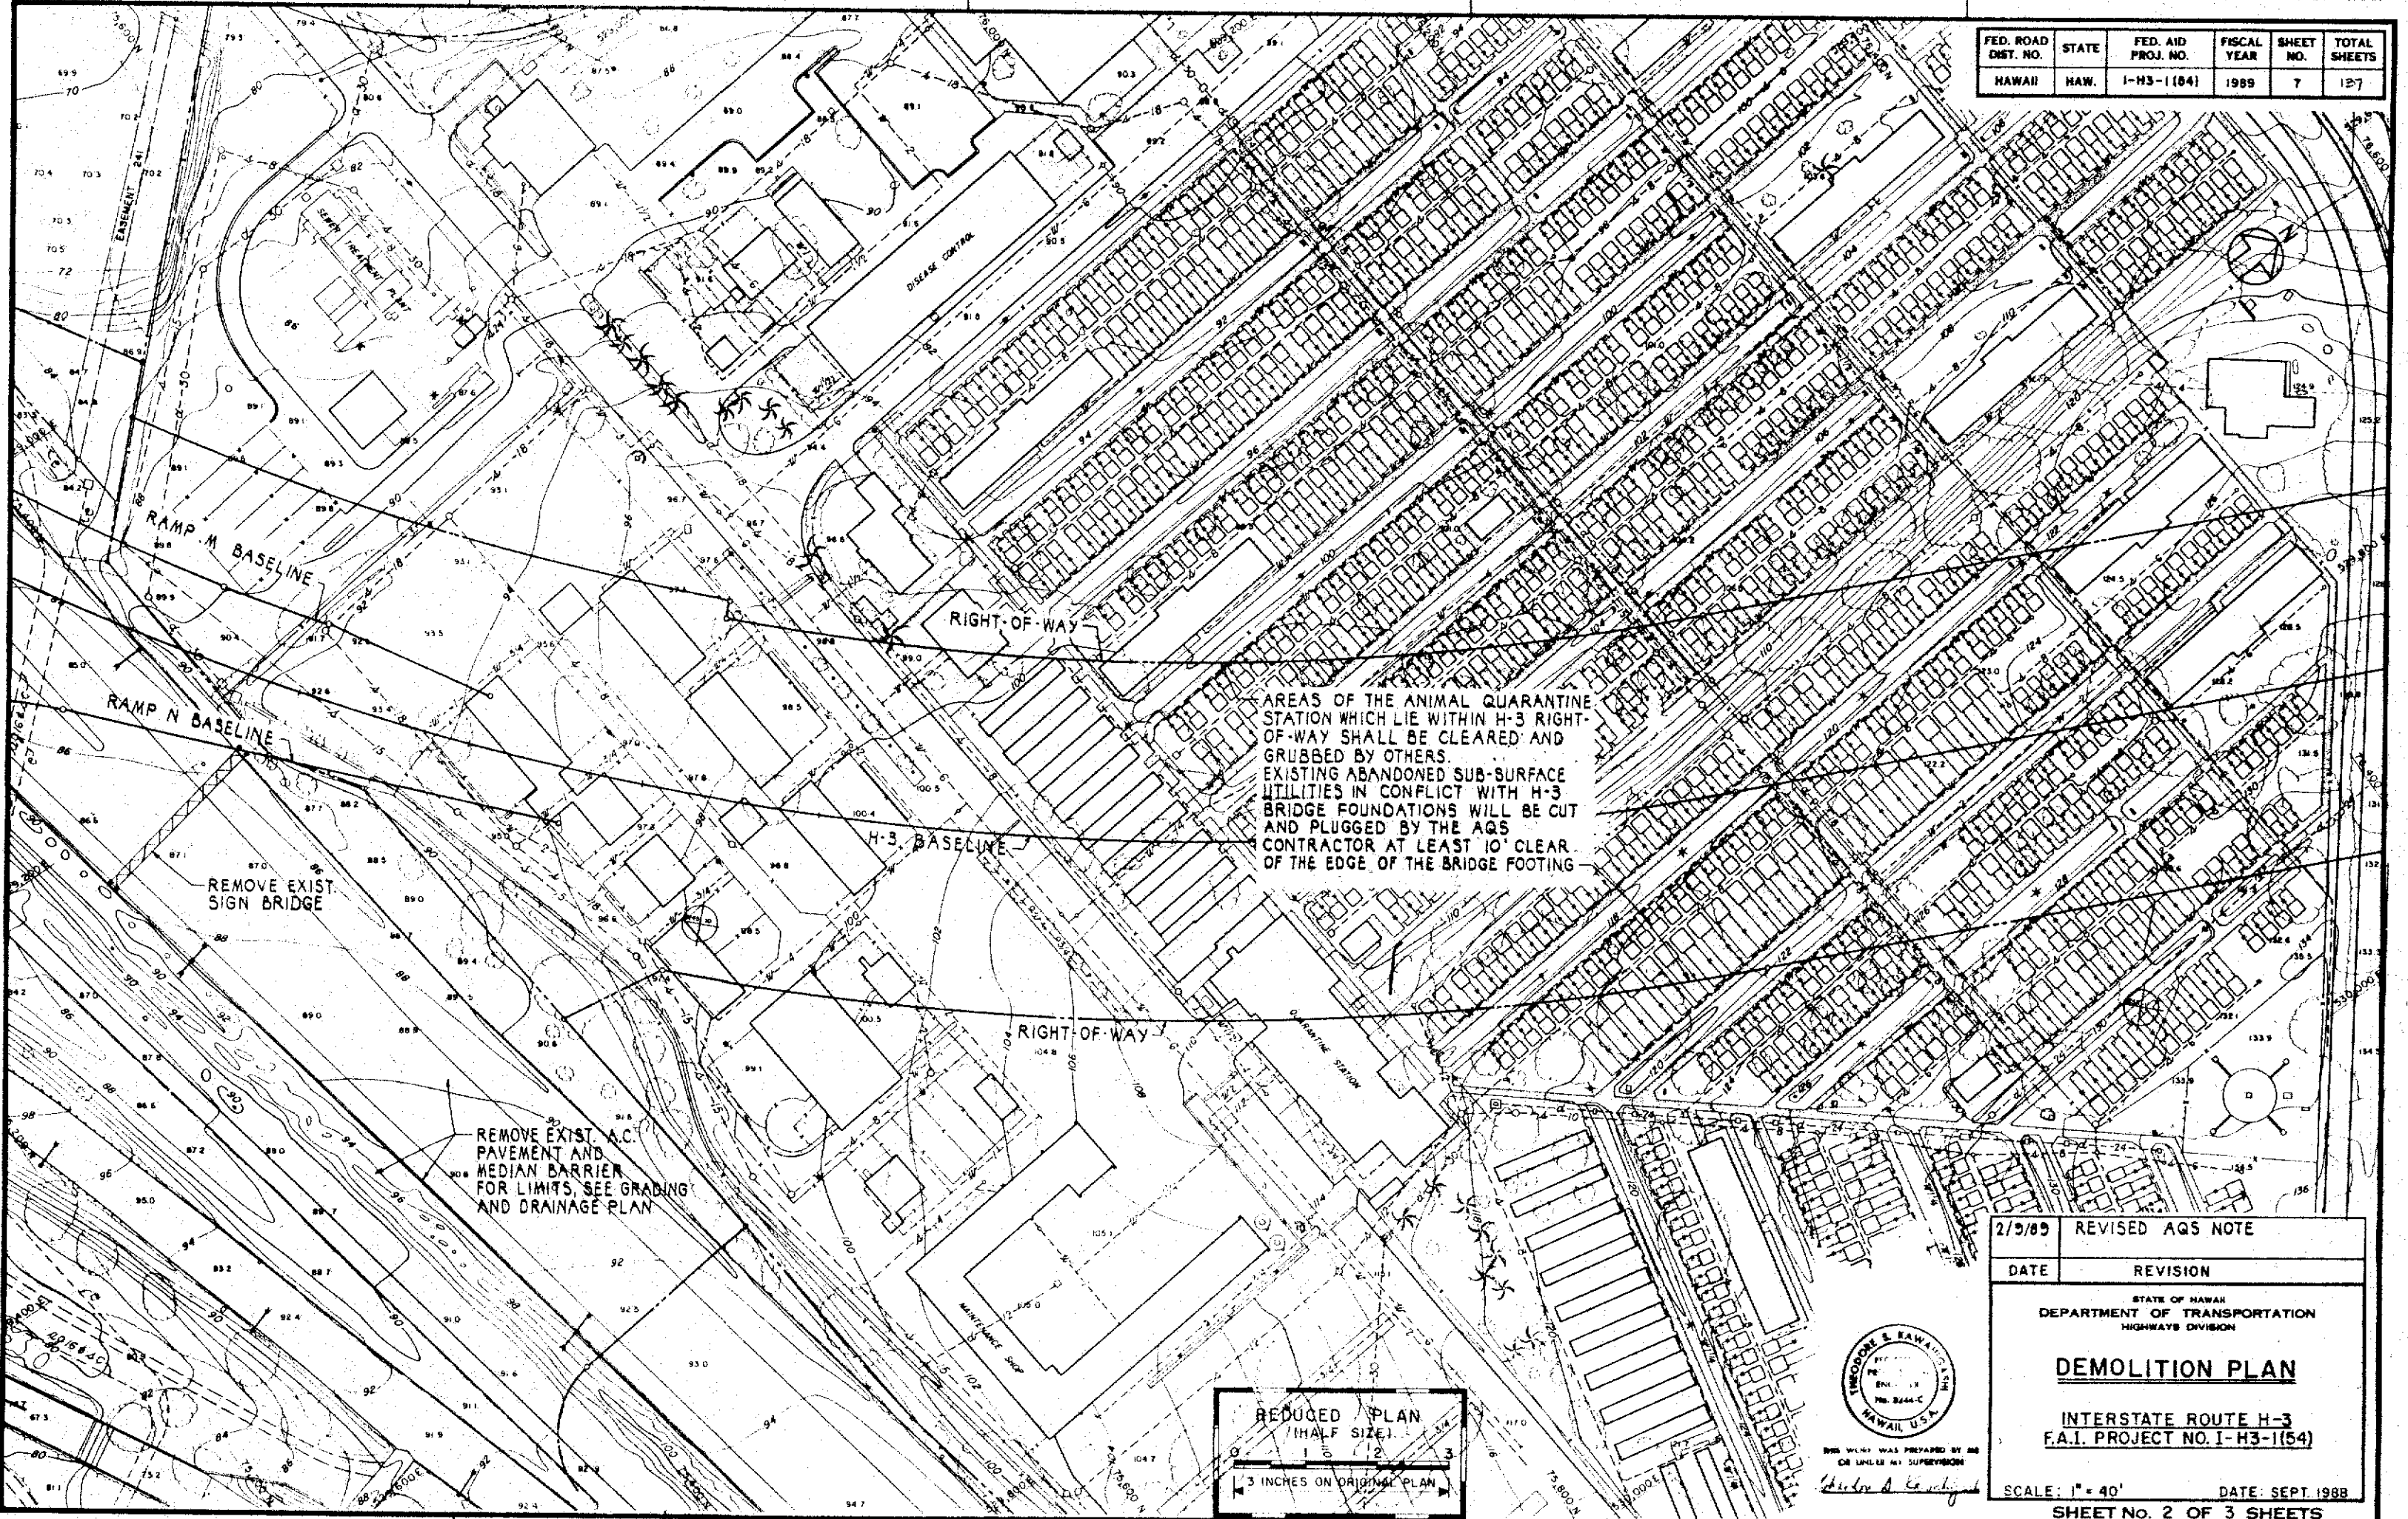

AREAS OF THE ANIMAL QUARANTINE STATION WHICH LIE WITHIN H-3 RIGHT-OF-WAY SHALL BE CLEARED AND GRUBBED BY OTHERS. EXISTING ABANDONED SUB-SURFACE UTILITIES IN CONFLICT WITH H-3 BRIDGE FOUNDATIONS WILL BE CUT AND PLUGGED BY THE AQS CONTRACTOR AT LEAST 10' CLEAR OF THE EDGE OF THE BRIDGE FOOTING

DATE	
SURVEY PLOTTED BY	
DRAWN BY	
TRACED BY	
NOTED BY	
CHECKED BY	
NO.	

REDUCED PLAN
(HALF SIZE)
1" = 40'
3 INCHES ON ORIGINAL PLAN

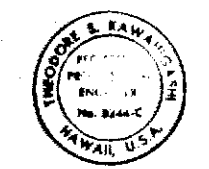

2/9/89

REVISED AQS NOTE

DATE	REVISION

STATE OF HAWAII

DEPARTMENT OF TRANSPORTATION

HIGHWAYS DIVISION

DEMOLITION PLAN

INTERSTATE ROUTE H-3

F.A.I. PROJECT NO. I-H3-1(184)

SCALE: 1" = 40'

DATE: SEPT. 1988


SHEET NO. 2 OF 3 SHEETS

ADD 7

FED. ROAD DIST. NO.	STATE	FED. AID PROJ. NO.	FISCAL YEAR	SHEET NO.	TOTAL SHEETS
HAWAII	HAW.	1-H3-1(54)	1989	8	127

DEMOLITION NOTES

1. FOR DISPOSITION OF EXISTING LIGHTING STANDARDS, PULL BOXES AND CONDUITS, SEE ELECTRICAL PLAN.
2. FOR DISPOSITION OF EXISTING TREES, SEE LANDSCAPE PLAN.

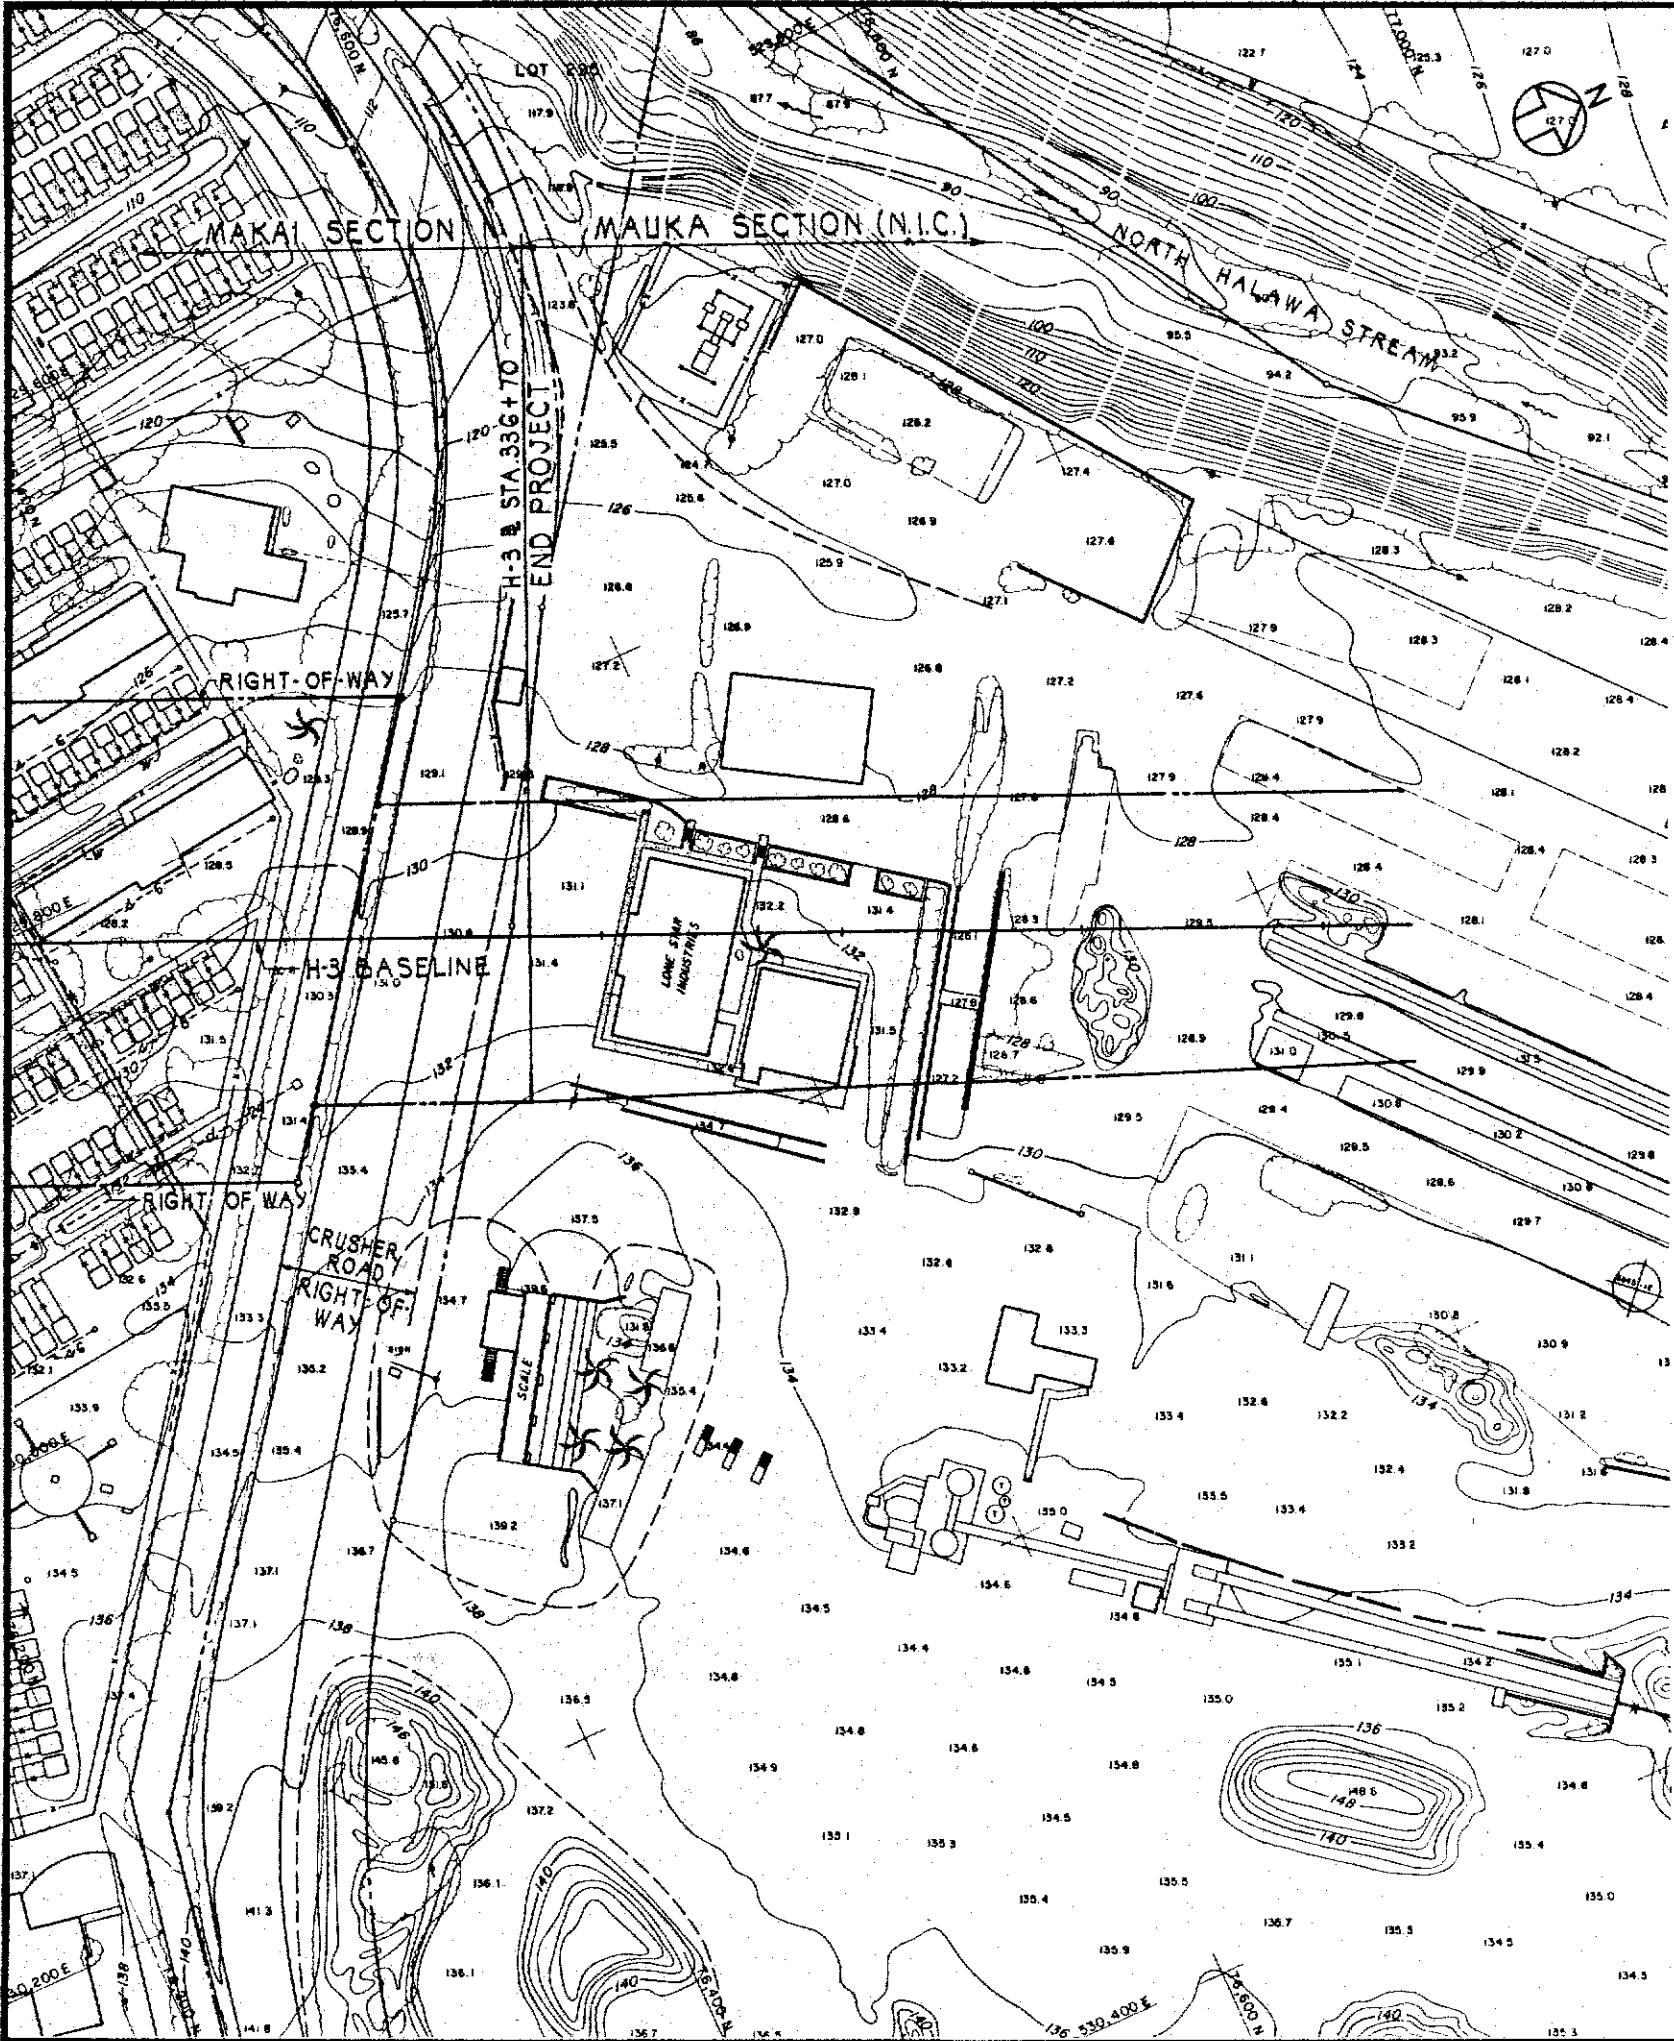

ORIGINAL PLAN	DATE
DRAWN BY	BY
CHECKED BY	CHECKED BY
NOTED BY	NOTED BY
QUANTITIES BY	QUANTITIES BY
CHECKED BY	CHECKED BY

REDUCED PLAN
(HALF SIZE)

0 1 2 3

3 INCHES ON ORIGINAL PLAN



THIS WORK WAS PREPARED BY ME
OR UNDER MY SUPERVISION
Theodore S. Kawahara

STATE OF HAWAII
DEPARTMENT OF TRANSPORTATION
HIGHWAYS DIVISION

DEMOLITION PLAN

INTERSTATE ROUTE H-3
F.A.I. PROJECT NO. 1-H3-1(54)

SCALE: 1" = 40' DATE: SEPT 1988

SHEET No. 3 OF 3 SHEETS