

INDEX TO DRAWINGS	
SHEET NO.	DESCRIPTION
1	TITLE SHEET
2	STANDARD PLANS SUMMARY
3	GENERAL PLAN
4 & 5	TYPICAL ROADWAY SECTIONS
6 TO 8	DEMOLITION PLAN
9 TO 11	GEOMETRICS PLAN
12 TO 16	PROFILE AND SE DIAGRAM
17 TO 19	RAMP TERMINAL DETAILS
20 TO 22	GRADING AND DRAINAGE PLAN
23	RIGID BARRIER DETAILS
24	DRAINAGE ESTIMATED QUANTITIES
25 & 26	DRAINAGE DETAILS & LINE PROFILES
27 TO 32	BRIDGE DECK DRAIN LAYOUT PLAN & DETAILS
33 TO 37	UTILITY PLAN, PROFILE & DETAILS
38 TO 40	LOG OF BORINGS
41 TO 44	SIGNING AND STRIPING PLAN & DETAILS
45 TO 55	CROSS SECTIONS
56 TO 62	ELECTRICAL PLANS & DETAILS
63 TO 74	LANDSCAPE PLANS & DETAILS
75 TO 84	STRUCTURAL DRAWINGS
85 TO 137	STRUCTURAL TYPICAL DRAWINGS
137 54	CONSTRUCTION SCHEDULE

STATE OF HAWAII
DEPARTMENT OF TRANSPORTATION
HIGHWAYS DIVISION





HONOLULU, HAWAII

PLANS FOR
CONSTRUCTION OF A PORTION OF
INTERSTATE ROUTE H-3
HALAWA QUARRY VIADUCT
MAKAI SECTION

FEDERAL AID INTERSTATE PROJECT NO. I-H3-1(54)


DISTRICT OF EWA
ISLAND OF OAHU

FED. ROAD DIST. NO.	STATE	FED. AID PROJ. NO.	FISCAL YEAR	SHEET NO.	TOTAL SHEETS
HAWAII	HAW.	I-H3-1(54)	1989	1	137

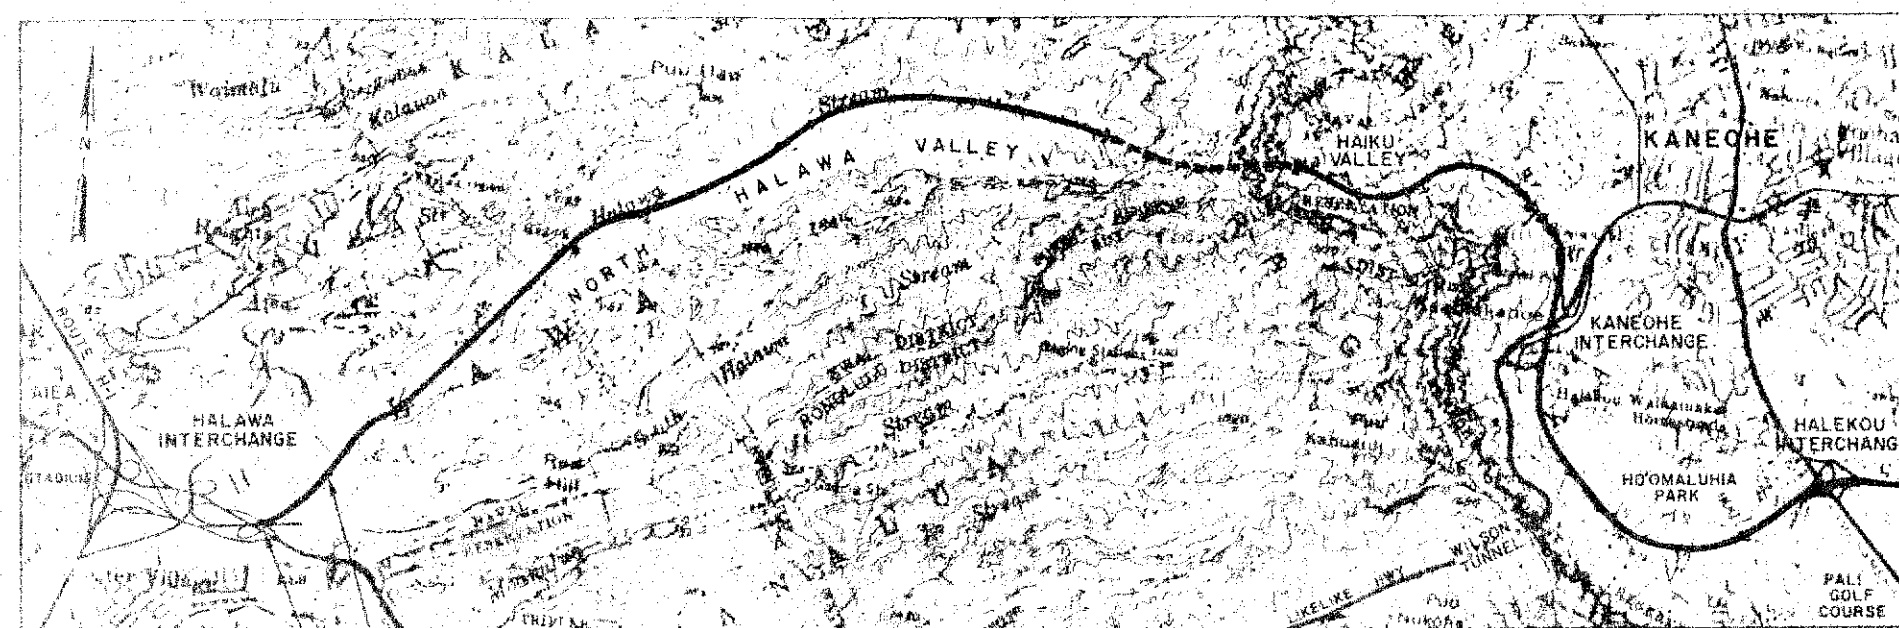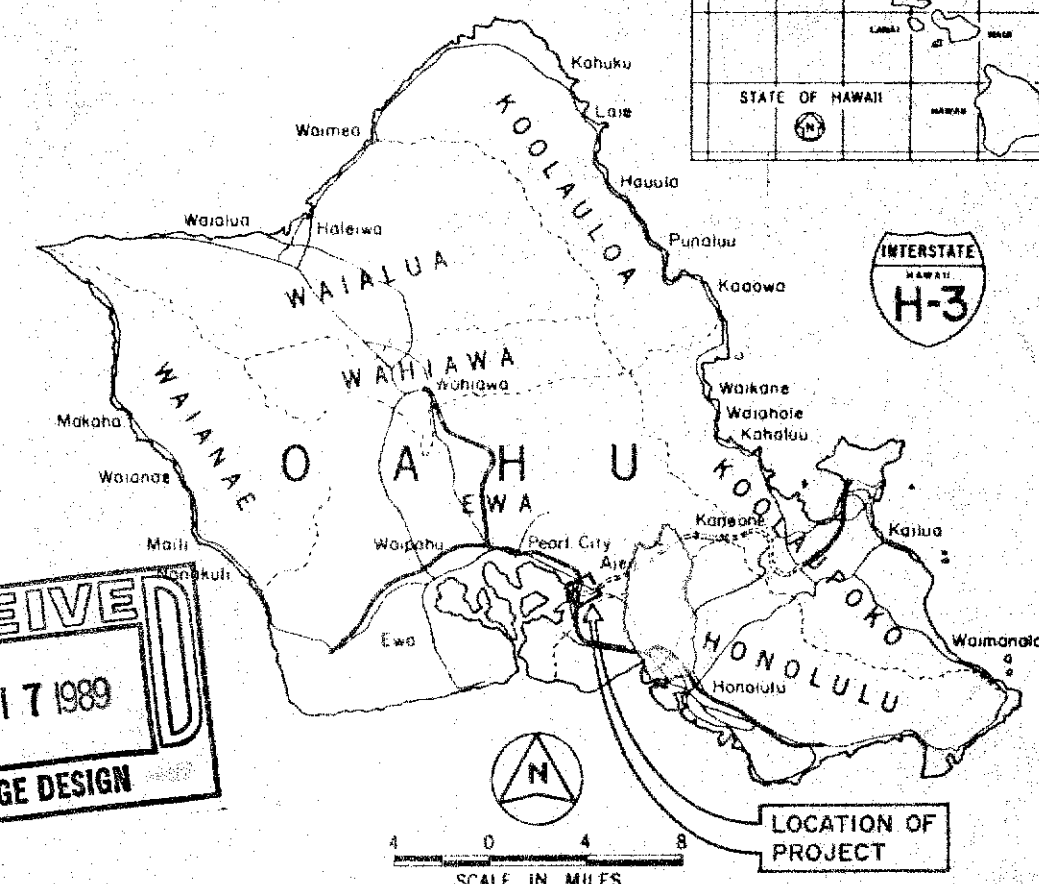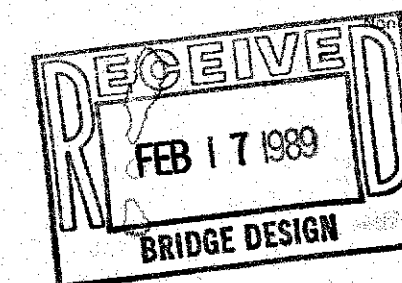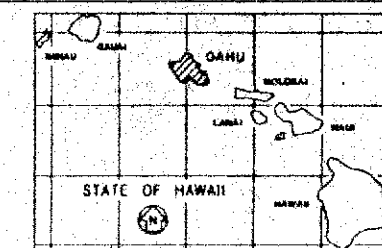

LAYOUT PLAN

SCALE IN MILES

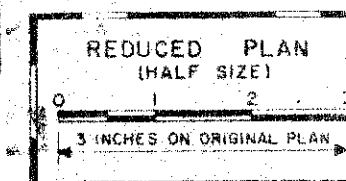

DESIGN CLASSIFICATION

DESIGN ADT (2008)	45,220
DHV	4,282
D	76/24
T	2.1%
T24	4.1%
V	60 MPH

BEGIN PROJECT @ STA. 333+27.85
END PROJECT @ STA. 356+70

LENGTH OF PROJECT = 0.44 MILE

1-25-89	ADDED CONSTRUCTION SCHEDULE SHEET
DATE	REVISION

DEPARTMENT OF TRANSPORTATION FEDERAL HIGHWAY ADMINISTRATION
APPROVED: <i>[Signature]</i> 7/26/88 DIVISION ADMINISTRATOR DATE

DEPARTMENT OF TRANSPORTATION STATE OF HAWAII
APPROVED: <i>[Signature]</i> 8/31/88 DIR. OF TRANSPORTATION DATE

SSFM ENGRS. INC. DESIGNED BY R. MIKAMI 548-7469 SEPT. 1988
PHONE DATE