

GENERAL

- 1 G1 TITLE SHEET
2 G2 KEY PLAN - 1
3 G3 KEY PLAN - 2
4 G4 KEY PLAN - 3
5 G5 LIST OF PLANS - 1
6 G6 LIST OF PLANS - 2
7 G7 LIST OF PLANS - 3
8 G8 STANDARD PLANS SUMMARY
9 G9 ABBREVIATIONS, LEGEND & NOTES
10 G10 MILESTONE SCHEDULE

MECHANICAL

STANDARDS

- 11 M1 HVAC - LEGEND, SYMB., ABBR. & GEN. NOTES
12 M2 PLUMBING - LEGEND, SYMB., ABBR. & GEN. NOTES
13 M3 HVAC EQUIPMENT SCHEDULES - 1
14 M4 HVAC EQUIPMENT SCHEDULES - 2
15 M5 HVAC EQUIPMENT SCHEDULES - 3
16 M6 HVAC EQUIPMENT SCHEDULES - 4
17 M7 MECHANICAL EQUIPMENT SCHEDULES - 1
18 M8 MECHANICAL EQUIPMENT SCHEDULES - 2
19 M9 HALAWA PORTAL BUILDINGS - HVAC AIRFLOW DIAGRAMS
20 M10 HAIKU PORTAL BUILDINGS - HVAC AIRFLOW DIAGRAMS
21 M11 CONTROL BUILDING - HVAC AIRFLOW DIAGRAM
22 M12 CROSSPASSAGES - HVAC AIRFLOW AND CONTROL DIAGRAMS
23 M13 HALAWA PORTAL BUILDINGS - HVAC CONTROL DIAGRAMS
24 M14 HAIKU PORTAL BUILDINGS - HVAC CONTROL DIAGRAMS
25 M15 CONTROL BUILDING - HVAC CONTROL DIAGRAMS
26 M16 PLUMBING - WATER BALANCE DIAGRAM
27 M17 PLUMBING - PIPING DIAGRAM
28 M18 PLUMBING - CONTROL DIAGRAMS
29 M19 EMERGENCY GENERATOR P&ID
30 M20 FIRE PROTECTION P&ID - 1
31 M21 FIRE PROTECTION P&ID - 2
32 M22 FIRE PROTECTION P&ID - 3
33 M23 HVAC - DETAILS - 1
34 M24 HVAC - DETAILS - 2
35 M25 HVAC - DETAILS - 3
36 M26 PLUMBING - DETAILS - 1
37 M27 PLUMBING - DETAILS - 2
38 M28 FIRE PROTECTION - DETAILS

HALAWA APPROACH

- 39 MA1 PLUMBING - DRAINAGE TRANSFER PUMP PLAN & SECTION
40 MA2 PLUMBING - WELL WATER PUMP PLAN & SECTION

HALAWA PORTAL BUILDING - IB

- 41 MN1 HVAC - LEVEL 1 & LEVEL 2 PARTIAL PLANS
42 MN2 HVAC - LEVEL 4 PARTIAL PLAN AND SECTION
43 MN3 HVAC - ELEVATOR EQUIPMENT ROOM PLAN AND DETAILS
44 MN4 PLUMBING - LEVEL 3 & LEVEL 4 PARTIAL PLANS
45 MN5 PLUMBING - PUMP ROOM PARTIAL PLANS & SECTION
46 MN6 PLUMBING - PARTIAL PLAN & PUMP ROOM SECTIONS
47 MN7 FIRE PROTECTION - LEVEL 2 & LEVEL 3 PARTIAL PLANS
48 MN8 FIRE PROTECTION - LEVEL 4 & ROOF PARTIAL PLANS

HALAWA PORTAL BUILDING - OB

- 49 MO1 HVAC - LEVEL 2 PARTIAL PLAN
50 MO2 HVAC - LEVEL 4 PARTIAL PLAN AND SECTION
51 MO3 HVAC - ELEVATOR EQUIPMENT ROOM PLAN AND DETAILS
52 MO4 PLUMBING - LEVEL 3 & LEVEL 4 PARTIAL PLANS
53 MO5 FIRE PROTECTION - LEVEL 2 & LEVEL 3 PARTIAL PLANS
54 MO6 FIRE PROTECTION - LEVEL 4 & ROOF PARTIAL PLANS

MECHANICAL (CONT.)

CONTROL BUILDING

- 55 MC1 HVAC - LEVEL 1 PARTIAL PLAN - 1
56 MC2 HVAC - LEVEL 1 PARTIAL PLAN - 2
57 MC3 HVAC - LEVEL 1 PARTIAL PLAN & SECTIONS
58 MC4 HVAC - LEVEL 2 PARTIAL PLAN - 1
59 MC5 HVAC - LEVEL 2 PARTIAL PLAN - 2
60 MC6 HVAC - LEVEL 2 PARTIAL PLAN - 3
61 MC7 HVAC - LEVEL 2 PARTIAL PLAN, SECTIONS & DETAILS
62 MC8 HVAC - LEVEL 3 MECHANICAL ROOM PLAN
63 MC9 HVAC - LEVEL 3 PARTIAL PLAN & SECTION
64 MC10 HVAC - EMERGENCY GENERATOR ROOF PLAN & SECTION
65 MC11 HVAC - SECTIONS & DETAIL
66 MC12 PLUMBING - LEVEL 1 PLAN
67 MC13 PLUMBING - LEVEL 2 PLANS
68 MC14 PLUMBING - LEVEL 3 & ROOF PLANS
69 MC15 PLUMBING - RISER DIAGRAMS
70 MC16 EMERGENCY GENERATOR PLAN
71 MC17 EMERGENCY GENERATOR SECTIONS & DETAILS
72 MC18 FIRE PROTECTION - LEVEL 1 & LEVEL 3 PLANS
73 MC19 FIRE PROTECTION - LEVEL 2 PLAN

TUNNELS

- 74 MT1 FIRE PROTECTION - VALVE STATION LOCATION PLAN
75 MT2 FIRE PROTECTION - SECTIONS & DETAILS
76 MT3 HVAC - CROSSPASSAGE PLAN

HAIKU APPROACH

- 77 MB1 PLUMBING - DRAINAGE TRANSFER PUMP PLAN & SECTION
78 MB2 PLUMBING - WELL WATER PUMP PLAN & SECTION

HAIKU PORTAL BUILDING - IB

- 79 MM1 HVAC - LEVEL A PARTIAL PLAN
80 MM2 HVAC - LEVEL 4 PARTIAL PLAN & SECTION
81 MM3 HVAC - ELEVATOR EQUIPMENT ROOMS - PLANS & DETAILS
82 MM4 PLUMBING - LEVEL 3 & LEVEL 4 PARTIAL PLANS
83 MM5 FIRE PROTECTION - LEVEL A PARTIAL PLAN
84 MM6 FIRE PROTECTION - LEVEL 2 & LEVEL 3 PARTIAL PLANS
85 MM7 FIRE PROTECTION - LEVEL 4 & ROOF PARTIAL PLANS

HAIKU PORTAL BUILDING - OB

- 86 MO1 HVAC - LEVEL A PARTIAL PLAN
87 MO2 HVAC - LEVEL 4 PARTIAL PLAN & SECTION
88 MO3 HVAC - ELEVATOR EQUIPMENT ROOMS - PLANS & DETAILS
89 MO4 PLUMBING - LEVEL 3 & LEVEL 4 PARTIAL PLANS
90 MO5 PLUMBING - PUMP ROOM PARTIAL PLAN & SECTION
91 MO6 PLUMBING - PUMP ROOM SECTIONS & PARTIAL PLAN
92 MO7 FIRE PROTECTION - LEVEL A PARTIAL PLAN
93 MO8 FIRE PROTECTION - LEVEL 2 & LEVEL 3 PARTIAL PLANS
94 MO9 FIRE PROTECTION - LEVEL 4 & ROOF PARTIAL PLANS

ELECTRICAL

STANDARDS

- 95 E1 ELECTRICAL LEGEND - 1
96 E2 ELECTRICAL LEGEND - 2
97 E3 LIGHTING FIXTURE SCHEDULE
98 E4 GROUNDING

DIAGRAMS

- 99 ED1 MAIN ONE LINE DIAGRAM
100 ED2 POWER FLOW DIAGRAM SWITCHING & INTERLOCKING
101 ED3 15 kV SWGR. ONE LINE HALAWA PORTAL BUILDING - IB
102 ED4 15 kV SWITCHGEAR LAYOUT HALAWA PORTAL BUILDING - IB
103 ED5 15 kV SWGR. METERING HECO REQUIREMENTS
104 ED6 15 kV SWITCHGEAR CIRCUIT BREAKER CONTROL

ELECTRICAL (CONT.)

DIAGRAMS - CONT.

- 105 ED7 15 kV SWITCHGEAR BUS TIE CONTROL
105S-1 ED7A 15 kV SWITCHGEAR CONTROL MODIFICATIONS
106 ED8 15 kV SWGR. ONE LINE HAIKU PORTAL BUILDING - IB
107 ED9 15 kV SWITCHGEAR LAYOUT HAIKU PORTAL BUILDING - IB
108 ED10 480V SWITCHGEAR LAYOUT HALAWA & HAIKU
109 ED11 480V SWITCHGEAR - CIRCUIT BREAKER CONTROL
110 ED12 480V SWITCHGEAR TIE BREAKER CONTROL
111 ED13 TUNNEL VENT FANS AFC LAYOUT
112 ED14 TUNNEL VENT FANS BLOCK DIAGRAM
113 ED15 TUNNEL VENT FANS SCHEMATIC DIAGRAM
114 ED16 TUNNEL VENT FANS AUXILIARY MCC
115 ED17 TUNNEL VENT FANS AUXILIARY APPARATUS
116 ED18 COMPUTER INTERFACE TERMINALS - ITC LIGHTING
117 ED19 EMERGENCY POWER ONE LINE
118 ED20 EMERGENCY POWER SCHEMATIC
119 ED21 THRESHOLD LTG. CONTROL HALAWA OB & HAIKU IB
120 ED22 LIGHTING PANEL SCHEDULES TUNNEL ENTRANCE - 1
121 ED23 LIGHTING PANEL SCHEDULES TUNNEL ENTRANCE - 2
122 ED24 TUNNEL ENTRANCE LIGHTING CIRCUIT LIST - 1
123 ED25 TUNNEL ENTRANCE LIGHTING CIRCUIT LIST - 2

HALAWA APPROACH

- 124 EA1 ONE LINE DIAGRAM AND PANEL SCHEDULES
124S-1 EA1A PANEL SCHEDULES
125 EA2 GROUNDING
126 EA3 POWER & LIGHTING WIRING - 1
127 EA4 POWER & LIGHTING WIRING - 2
127S-1 EA4A LIGHTING POLE SCHEDULE
128 EA5 ELECTRICAL VAULT LAYOUT
129 EA6 POWER WIRING UTILITY TUNNEL
130 EA7 LIGHTING WIRING UTILITY TUNNEL

HALAWA PORTAL BUILDING - IB

- 131 EN1 ONE LINE DIAGRAM HALAWA IB SUBSTATION
132 EN2 ONE LINE DIAGRAM 480Y/277V POWER
133 EN3 RISER DIAGRAM POWER

SURVEY PLOTTED BY	DATE
DRAWN BY	JUL 90
CHECKED BY	JUL 90
DESIGNED BY	JUL 90
QUANTITIES BY	JUL 90
CHECKED BY	JUL 90
NO.	



THIS WORK WAS PREPARED BY ME
OR UNDER MY SUPERVISION
William H. Harnish

DATE	REVISION
STATE OF HAWAII DEPARTMENT OF TRANSPORTATION HIGHWAYS DIVISION	
LIST OF PLANS - 1	
GENERAL INTERSTATE ROUTE H-3 F.A.I. PROJ. NO. I-H3-1(66)	
SCALE: NONE	DATE: APR 1992
SHEET NO. G5	OF 10 SHEETS

SHEET SHEET
NO. TITLE

ELECTRICAL (CONT.)

HALAWA PORTAL BUILDING -IB CONT.

134 EN4 RISER DIAGRAM CONTROL
135 EN5 BLOCK DIAGRAM CONTROL
136 EN6 GROUNDING
137 EN7 POWER WIRING LEVEL 1 PLAN
138 EN8 POWER WIRING LEVEL 2 PLAN
139 EN9 POWER WIRING LEVEL 3 PLAN
140 EN10 POWER WIRING LEVEL 4 PLAN
141 EN11 POWER WIRING ROOF PLAN
142 EN12 GENERAL ARRANGEMENT 480V BUS DUCT
143 EN13 LIGHTING WIRING LEVEL 1 PLAN
144 EN14 LIGHTING WIRING LEVEL 2 PLAN
145 EN15 LIGHTING WIRING LEVEL 3 PLAN
146 EN16 LIGHTING WIRING LEVEL 4 PLAN
147 EN17 LIGHTING WIRING ROOF PLAN
148 EN18 LIGHTING & RECEPTACLES STAIR 1 & 2
149 EN19 LIGHTING & RECEPTACLES STAIR 3
150 EN20 LIGHTING PANEL SCHEDULES
151 EN21 LIGHTING INSTALLATION DETAILS - 1
152 EN22 LIGHTING INSTALLATION DETAILS - 2

HALAWA PORTAL BUILDING - OB

153 E01 ONE LINE DIAGRAM HALAWA OB SUBSTATION
154 E02 ONE LINE DIAGRAM 480Y/277V POWER
155 E03 RISER DIAGRAM POWER
156 E04 RISER DIAGRAM CONTROL
157 E05 BLOCK DIAGRAM CONTROL
158 E06 GROUNDING
159 E07 POWER WIRING LEVEL 1 PLAN
160 E08 POWER WIRING LEVEL 2 PLAN
161 E09 POWER WIRING LEVEL 3 PLAN
162 E010 POWER WIRING LEVEL 4 PLAN
163 E011 POWER WIRING ROOF PLAN
164 E012 GENERAL ARRANGEMENT 480V BUS DUCT
165 E013 LIGHTING WIRING LEVEL 1 PLAN
166 E014 LIGHTING WIRING LEVEL 2 PLAN
167 E015 LIGHTING WIRING LEVEL 3 PLAN
168 E016 LIGHTING WIRING LEVEL 4 PLAN
169 E017 LIGHTING WIRING ROOF PLAN
170 E018 LIGHTING & RECEPTACLES STAIR 1 & 2
171 E019 LIGHTING & RECEPTACLES STAIR 3
172 E020 LIGHTING PANEL SCHEDULES
173 E021 LIGHTING INSTALLATION DETAILS - 1
174 E022 LIGHTING INSTALLATION DETAILS - 2

CONTROL BUILDING

175 EC1 POWER WIRING LEVEL 1 PLAN
176 EC2 POWER WIRING LEVEL 2 PLAN
177 EC3 POWER WIRING LEVEL 3 PLAN
178 EC4 LIGHTING LEVEL 1 PLAN
179 EC5 LIGHTING LEVEL 2 PLAN
180 EC6 LIGHTING LEVEL 3 PLAN
181 EC7 LIGHTING PANEL SCHEDULES - 1
182 EC8 LIGHTING PANEL SCHEDULES - 2
183 EC9 POWER WIRING EMERGENCY GENERATOR

SHEET SHEET
NO. TITLE

ELECTRICAL (CONT.)

TUNNELS

184 ET1 ONE LINE DIAGRAM POWER
185 ET2 CONTROL DIAGRAM - INTERIOR LIGHTING
186 ET3 GROUNDING
187 ET4 POWER WIRING PORTAL TO STA 607+50
188 ET5 POWER WIRING STA. 607+50 TO 612+40
189 ET6 POWER WIRING STA. 612+40 TO 617+30
190 ET7 POWER WIRING STA. 617+30 TO 622+20
191 ET8 POWER WIRING STA. 622+20 TO 627+10
192 ET9 POWER WIRING STA. 627+10 TO 632+00
193 ET10 POWER WIRING STA. 632+00 TO 636+90
194 ET11 POWER WIRING STA. 636+90 TO 641+80
195 ET12 POWER WIRING STA. 641+80 TO 646+70
196 ET13 POWER WIRING STA. 646+70 TO 651+60
197 ET14 POWER WIRING STA. 651+60 TO PORTAL
198 ET15 POWER WIRING CROSSPASSAGES
199 ET16 TUNNEL LIGHTING DISTRIBUTION DIAGRAM
200 ET17 LIGHTING PLAN - HALAWA PORTAL
201 ET18 LIGHTING PLAN PORTAL TO STA. 607+50
202 ET19 LIGHTING PLAN - STA. 607+50 TO 612+40
203 ET20 LIGHTING PLAN - STA. 612+40 TO 617+30
204 ET21 LIGHTING PLAN - STA. 617+30 TO 622+20
205 ET22 LIGHTING PLAN - STA. 622+20 TO 627+10
206 ET23 LIGHTING PLAN - STA. 627+10 TO 632+00
207 ET24 LIGHTING PLAN - STA. 632+00 TO 636+90
208 ET25 LIGHTING PLAN - STA. 636+90 TO 641+80
209 ET26 LIGHTING PLAN - STA. 641+80 TO 646+70
210 ET27 LIGHTING PLAN - STA. 646+70 TO 651+60
211 ET28 LIGHTING PLAN - STA. 651+60 TO PORTAL
212 ET29 LIGHTING PLAN - HAIKU PORTAL
213 ET30 LIGHTING WIRING CROSSPASSAGES
214 ET31 RECEPTACLES & PLENUM LIGHTING DETAILS
215 ET32 CROSSPASSAGE SECTION & DETAILS - 1
216 ET33 CROSSPASSAGE SECTION & DETAILS - 2
217 ET34 LUMINAIRE DETAILS
218 ET35 LUMINAIRE INSTALLATION DETAILS
219 ET36 CROSSPASSAGEWAY PANEL SCHEDULES - 1
220 ET37 CROSSPASSAGEWAY PANEL SCHEDULES - 2
221 ET38 CROSSPASSAGEWAY PANEL SCHEDULES - 3
222 ET39 CROSSPASSAGEWAY PANEL SCHEDULES - 4
223 ET40 CROSSPASSAGEWAY PANEL SCHEDULES - 5

HAIKU APPROACH

224 EB1 ONE LINE DIAGRAM AND PANEL SCHEDULE
225 EB2 GROUNDING
226 EB3 POWER & LIGHTING WIRING - 1
227 EB4 POWER & LIGHTING WIRING - 2
228 EB5 POWER & LIGHTING WIRING - 3
229 EB6 ELECTRICAL VAULT LAYOUT
230 EB7 VIADUCT POWER & LIGHTING WIRING - 1
231 EB8 VIADUCT POWER & LIGHTING WIRING - 2
232 EB9 VIADUCT POWER & LIGHTING WIRING - 3
233 EB10 VIADUCT POWER & LIGHTING WIRING - 4
234 EB11 VIADUCT POWER & LIGHTING WIRING - 5
235 EB12 VIADUCT POWER & LIGHTING WIRING - 6
236 EB13 VIADUCT POWER & LIGHTING WIRING - 7
237 EB14 VIADUCT POWER & LIGHTING WIRING - 8
238 EB15 VIADUCT POWER & LIGHTING WIRING - 9
239 EB16 VIADUCT POWER & LIGHTING WIRING - 10
240 EB17 VIADUCT POWER & LIGHTING WIRING - 11
241 EB18 VIADUCT POWER & LIGHTING WIRING - 12
242 EB19 INSTALLATION DETAILS

SHEET SHEET
NO. TITLE

ELECTRICAL (CONT.)

HAIKU PORTAL BUILDING - IB


243 EM1 ONE LINE DIAGRAM HAIKU IB SUBSTATION
244 EM2 ONE LINE DIAGRAM 480Y/277V POWER
245 EM3 RISER DIAGRAM POWER
246 EM4 RISER DIAGRAM CONTROL
247 EM5 BLOCK DIAGRAM CONTROL
248 EM6 GROUNDING
249 EM7 POWER WIRING LEVEL A PLAN
250 EM8 POWER WIRING LEVEL 1 PLAN
251 EM9 POWER WIRING LEVEL 2 PLAN
252 EM10 POWER WIRING LEVEL 3 PLAN
253 EM11 POWER WIRING LEVEL 4 PLAN
254 EM12 POWER WIRING ROOF PLAN
255 EM13 GENERAL ARRANGEMENT 480V BUS DUCT
256 EM14 LIGHTING WIRING LEVEL A PLAN
257 EM15 LIGHTING WIRING LEVEL 1 PLAN
258 EM16 LIGHTING WIRING LEVEL 2 PLAN
259 EM17 LIGHTING WIRING LEVEL 3 PLAN
260 EM18 LIGHTINGS WIRING LEVEL 4 PLAN
261 EM19 LIGHTING WIRING ROOF PLAN
262 EM20 LIGHTING & RECEPTACLES STAIR 1
263 EM21 LIGHTING & RECEPTACLES STAIR 2
264 EM22 LIGHTING & RECEPTACLES STAIR 3 PLAN
265 EM23 LIGHTING PANEL SCHEDULES
266 EM24 LIGHTING INSTALLATION DETAILS - 1
267 EM25 LIGHTING INSTALLATION DETAILS - 2

HAIKU PORTAL BUILDING - OB

268 E01 ONE LINE DIAGRAM HAIKU OB SUBSTATION
269 E02 ONE LINE DIAGRAM 480Y/277V POWER
270 E03 RISER DIAGRAM POWER
271 E04 RISER DIAGRAM CONTROL
272 E05 BLOCK DIAGRAM CONTROL
273 E06 GROUNDING
274 E07 POWER WIRING LEVEL A PLAN
275 E08 POWER WIRING LEVEL 1 PLAN
276 E09 POWER WIRING LEVEL 2 PLAN
277 E010 POWER WIRING LEVEL 3 PLAN
278 E011 POWER WIRING LEVEL 4 PLAN
279 E012 POWER WIRING ROOF PLAN
280 E013 GENERAL ARRANGEMENT 480V BUS DUCT
281 E014 LIGHTING WIRING LEVEL A PLAN
282 E015 LIGHTING WIRING LEVEL 1 PLAN
283 E016 LIGHTING WIRING LEVEL 2 PLAN
284 E017 LIGHTING WIRING LEVEL 3 PLAN
285 E018 LIGHTING WIRING LEVEL 4 PLAN
286 E019 LIGHTING WIRING ROOF PLAN
287 E020 LIGHTING & RECEPTACLES - STAIR 1
288 E021 LIGHTING & RECEPTACLES - STAIR 2
289 E022 LIGHTING & RECEPTACLES - STAIR 3
290 E023 LIGHTING PANEL SCHEDULES
291 E024 LIGHTING INSTALLATION DETAILS - 1
292 E025 LIGHTING INSTALLATION DETAILS - 2

FED. ROAD DIST. NO.	STATE	FED. AID PROJ. NO.	FISCAL YEAR	SHEET NO.	TOTAL SHEETS
HAWAII	HAW.	I-H3-I(66)	1992	6	440

SURVEY PLOTTED BY	DATE
DRN BY	JUL 90
TRACED BY	JUL 90
DESIGNED BY	M. CHU
CHECKED BY	H. LIN
ORIGINAL PLAN	
NOTE BOOK	
NO.	

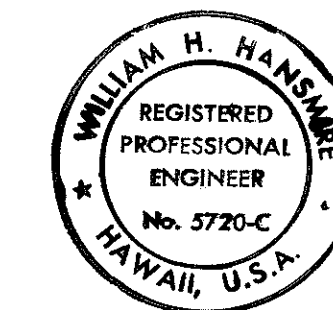

THIS WORK WAS PREPARED BY ME
OR UNDER MY SUPERVISION

William H. Hansen

DATE	REVISION
STATE OF HAWAII DEPARTMENT OF TRANSPORTATION HIGHWAYS DIVISION	
LIST OF PLANS - 2	
GENERAL INTERSTATE ROUTE H-3 F.A.I. PROJ. NO. I-H3-I(66)	
SCALE: NONE	DATE: APR 1992
SHEET NO. G6	OF 10 SHEETS

FED. ROAD DIST. NO.	STATE	FED. AID PROJ. NO.	FISCAL YEAR	SHEET NO.	TOTAL SHEETS
HAWAII	HAW.	I-H3-1(66)	1992	7	440

SHEET SHEET
NO. TITLE

ELECTRICAL (CONT.)

TEMPORARY POWER DEMOLITION

293 EP1 HALAWA ACCESS ROAD OVERHEAD POWER LINE DEMOLITION PLAN
294 EP2 HAIKU ACCESS ROAD OVERHEAD POWER LINE DEMOLITION PLAN

ARCHITECTURAL

STANDARDS

295 A1 ARCHITECTURAL ABBREVIATIONS
296 A2 LEGENDS AND SCHEDULES
297 A3 ROOF & MISCELLANEOUS DETAILS
298 A4 SKYLIGHT DETAILS
299 A5 ROOF ACCESS DETAILS
300 A6 DOOR AND GATE DETAILS
301 A7 SPECIAL DOOR DETAILS
302 A8 LOUVER DETAILS - 1
303 A9 LOUVER DETAILS - 2
304 A10 ELEVATOR DETAILS
305 A11 WINDOW AND STOREFRONT DETAILS
306 A12 MISCELLANEOUS INTERIOR DETAILS - 1
307 A13 MISCELLANEOUS INTERIOR DETAILS - 2
308 A14 MISCELLANEOUS INTERIOR DETAILS - 3
309 A15 MISCELLANEOUS DETAILS
309S-1 A15A HAIKU PORTAL BUILDINGS SKYLIGHT DETAILS

HALAWA PORTAL BUILDING - IB

310 AN1 LEVEL 1 PLAN
311 AN2 LEVEL 2 PLAN
312 AN3 LEVEL 3 PLAN
313 AN4 LEVEL 4 PLAN
314 AN5 ROOF LEVEL PLAN
315 AN6 ELEVATOR AND STAIRS 1 & 2
316 AN7 SECTIONS AT ELEVATOR

HALAWA PORTAL BUILDING - OB

317 A01 LEVEL 1 PLAN
318 A02 LEVEL 2 PLAN
319 A03 LEVEL 3 PLAN
320 A04 LEVEL 4 PLAN
321 A05 ROOF LEVEL PLAN
322 A06 ELEVATOR AND STAIRS 1 & 2
323 A07 SECTIONS AT ELEVATOR

CONTROL BUILDING

324 AC1 PLAN - LEVEL 1
325 AC2 PLAN - LEVEL 2
326 AC3 PLAN - LEVEL 3
327 AC4 ROOF PLAN
328 AC5 WEST AND EAST ELEVATIONS AND SECTIONS
329 AC6 NORTH ELEVATIONS
330 AC7 SOUTH ELEVATIONS
331 AC8 ELEVATION LINE B AND SECTION ON LINE D
332 AC9 PARTIAL WALL ELEVATIONS
333 AC10 WALL SECTIONS - 1
334 AC11 WALL SECTIONS - 2
335 AC12 STAIRS & ELEVATOR
336 AC13 PARTIAL PLANS AND INTERIOR ELEVATIONS
337 AC14 REFLECTED CEILING PLANS
338 AC15 INTERIOR ELEVATIONS

SHEET SHEET
NO. TITLE

ARCHITECTURAL (CONT.)

TUNNELS

339 AT1 CROSSPASSAGE ELEVATIONS & DETAILS
340 AT2 MISCELLANEOUS TUNNEL DETAILS - 1
341 AT3 MISCELLANEOUS TUNNEL DETAILS - 2
342 AT4 MISCELLANEOUS TUNNEL DETAILS - 3
343 AT5 MISCELLANEOUS TUNNEL DETAILS - 4

HAIKU PORTAL BUILDING - IB

344 AM1 LEVEL A PLAN
345 AM2 LEVEL 1 PLAN
346 AM3 LEVEL 2 PLAN
347 AM4 LEVEL 3 PLAN
348 AM5 LEVEL 4 PLAN
349 AM6 ROOF LEVEL PLAN
350 AM7 ELEVATOR AND STAIR 1
351 AM8 ELEVATOR AND STAIR 2
352 AM9 SECTIONS AT ELEVATOR

HAIKU PORTAL BUILDING - OB

353 A01 LEVEL A PLAN
354 A02 LEVEL 1 PLAN
355 A03 LEVEL 2 PLAN
356 A04 LEVEL 3 PLAN
357 A05 LEVEL 4 PLAN
358 A06 ROOF LEVEL PLAN
359 A07 ELEVATOR AND STAIR 1
360 A08 ELEVATOR AND STAIR 2
361 A09 SECTIONS AT ELEVATOR

CONTROL BUILDING

362 A11 CONTROL BLDG. LAYOUT INTERIOR FINISH PLAN
362S-1 A11A ELECTRONIC SHOP/GARAGE EQUIPMENT PLAN
362S-2 A11B CONTROL BLDG. LAYOUT INTERIOR SIGNS

STRUCTURAL

SUPPORT STRUCTURES

363 SS1 GENERAL NOTES
364 SS2 HALAWA APPROACH - LAYOUT PLAN
365 SS3 HAIKU APPROACH - LAYOUT PLAN 1
366 SS4 HAIKU APPROACH - LAYOUT PLAN 2
367 SS5 HAIKU APPROACH - LAYOUT PLAN 3
368 SS6 HALAWA APPROACH - SECTION 1
369 SS7 HALAWA APPROACH - SECTION 2
370 SS8 HALAWA APPROACH - SECTION 3
371 SS9 HAIKU APPROACH - SECTION 1
372 SS10 HAIKU APPROACH - SECTION 2
373 SS11 HAIKU APPROACH - SECTION 3
374 SS12 HAIKU APPROACH - SECTION 4
375 SS13 HAIKU APPROACH - SECTION 5
376 SS14 HAIKU APPROACH - SECTION 6
377 SS15 SUPPORT POST SCHEDULE
378 SS16 SUPPORT POST DETAILS - 1
379 SS17 SUPPORT POST DETAILS - 2
380 SS18 TRUSS FRAMING DETAILS

SHEET SHEET
NO. TITLE

STRUCTURAL (CONT.)

SUPPORT STRUCTURES

381 SS19 TRUSS CONNECTION DETAILS - 1
382 SS20 TRUSS CONNECTION DETAILS - 2
383 SS21 TRUSS CONNECTION DETAILS - 3
384 SS22 TRUSS CONNECTION DETAILS - 4
385 SS23 FM SIGN CONNECTION DETAILS
386 SS24 VM SIGN CONNECTION DETAILS
387 SS25 HALAWA APPROACH - WALKWAY PLANS
388 SS26 HAIKU APPROACH - WALKWAY PLANS
389 SS27 WALKWAY DETAILS - 1
390 SS28 WALKWAY DETAILS - 2
391 SS29 MISCELLANEOUS DETAILS - 1
392 SS30 MISCELLANEOUS DETAILS - 2
393 SS31 MISCELLANEOUS DETAILS - 3
394 SS32 MISCELLANEOUS DETAILS - 4
395 SS33 MISCELLANEOUS DETAILS - 5
395S-1 SS33A MISCELLANEOUS DETAILS - 5A
396 SS34 MISCELLANEOUS DETAILS - 6
397 SS35 MISCELLANEOUS DETAILS - 7
398 SS36 MISCELLANEOUS DETAILS - 8

SYSTEMS

SIGNING & STRIPING

399 TX1 HALAWA CROSSOVER PLAN
400 TX2 TUNNEL PLAN - 1
401 TX3 TUNNEL PLAN - 2
402 TX4 TUNNEL PLAN - 3
403 TX5 TUNNEL PLAN - 4
404 TX6 HAIKU CROSSOVER PLAN
405 TX7 HALAWA CROSSOVER DETAIL
406 TX8 HAIKU CROSSOVER DETAIL
407 TX9 STRIPING DETAILS
408 TX10 SIGNING DETAILS - 1
409 TX11 SIGNING DETAILS - 2
410 TX12 MOUNTING DETAILS

SPECIAL

HAIKU O & M FACILITY

411 PB1 SITE PLAN
412 PB2 ARCHITECTURAL STANDARD DETAILS - 1
413 PB3 ARCHITECTURAL STANDARD DETAILS - 2
414 PB4 ARCHITECTURAL LEVEL A PLAN - IB
415 PB5 ARCHITECTURAL ROOF PLAN - IB
416 PB6 ARCHITECTURAL REFLECTED CEILING PLAN - IB
417 PB7 ARCHITECTURAL SECTIONS & ELEVATIONS
418 PB8 ARCHITECTURAL LEVEL A PLAN - OB
419 PB9 ARCHITECTURAL ROOF PLAN - OB
420 PB10 ARCHITECTURAL REFLECTED CEILING PLAN - OB
421 PB11 ARCHITECTURAL SECTIONS & ELEVATIONS - OB
422 PB12 ARCHITECTURAL ENLARGED PLAN & ELEVATIONS-OB
423 PB13 ARCHITECTURAL ENLARGED ELEVATIONS
423S-1 PB13A ARCHITECTURAL EQUIPMENT PLAN IB & LEGEND
423S-2 PB13B ARCHITECTURAL EQUIPMENT & FURNISHINGS PLAN OB
424 PB14 STRUCTURAL GENERAL NOTES & STANDARD DETAILS
425 PB15 STRUCTURAL FOUNDATION PLAN & DETAILS - IB
426 PB16 STRUCTURAL ROOF FRAMING PLAN & DETAILS - IB
427 PB17 STRUCTURAL ELEVATION & WALL PANELS - IB
428 PB18 STRUCTURAL FOUNDATION PLAN & DETAILS - OB



THIS WORK WAS PREPARED BY ME
OR UNDER MY SUPERVISION

William H. Hanawa

SPECIAL (CONT.)

HAIKU O & M FACILITY (CONT.)

429 PB19 STRUCTURAL ROOF FRAMING PLAN & DETAILS - OB
430 PB20 STRUCTURAL ELEVATION & WALL PANELS - OB
431 PB21 MECHANICAL HVAC - IB
432 PB22 MECHANICAL HVAC - OB
433 PB23 MECHANICAL PLUMBING PLAN & RISER DIAGRAMS
433S-1 PB23A MECHANICAL PLUMBING PLANS
434 PB24 MECHANICAL FIRE PROTECTION PLANS - IB & OB
435 PB25 ELECTRICAL POWER & LIGHTING-IB
436 PB26 ELECTRICAL POWER PLAN - OB
437 PB27 ELECTRICAL LIGHTING, TELEPHONE AND FIRE ALARM PLANS-OB
438 PB28 ELECTRICAL PANEL SCHEDULES

HAIKU OMEGA TRANSMITTER FACILITY

439 OB1 GROUND SYSTEM MODIFICATION - 1
440 OB2 GROUND SYSTEM MODIFICATION - 2
440S-1 TO 440S-11 REFERENCE SHEETS

REFERENCE PLANS

PROJ. TOTAL SHT. TITLE
SHT. NO. SHTS. NO.

EXPLORATORY TUNNEL - F.A.I. PROJ. NO. I-H3-1(37)

16	26	1	OVERHEAD POWER LINE 11.5 KV LAYOUT - HALAWA
17	26	2	OVERHEAD POWER LINE 11.5 KV LAYOUT - HALAWA
18	26	3	OVERHEAD POWER LINE 11.5 KV LAYOUT - HALAWA
19	26	4	OVERHEAD POWER LINE 11.5 KV LAYOUT - HALAWA
20	26	1	OVERHEAD POWER LINE 12.47 KV LAYOUT - HAIKU
21	26	2	OVERHEAD POWER LINE 12.47 KV LAYOUT - HAIKU
22	26	3	OVERHEAD POWER LINE 12.47 KV LAYOUT - HAIKU
23	26	4	OVERHEAD POWER LINE 12.47 KV LAYOUT - HAIKU
24	26	-	OVERHEAD POWER LINE POLE METERING DETAILS
25	26	-	OVERHEAD POWER LINE POWER LINE DETAILS
26	26	-	OVERHEAD POWER LINE SUBSTATION LAYOUT

DATE	JUL 90
DESIGNED BY	K. CHU
CHECKED BY	M. LIN
ORIGINAL PLAN	
NOTE BOOK	
NO.	

7/22/92	ADDENDUM 1 - ADDED SHT. NO. PB13A PB13B, PB23A & A11A
DATE	REVISION
STATE OF HAWAII DEPARTMENT OF TRANSPORTATION HIGHWAYS DIVISION	
LIST OF PLANS - 3	
GENERAL	
INTERSTATE ROUTE H-3 F.A.I. PROJ. NO. I-H3-1(66)	
SCALE: 1/8" = 1'-0"	DATE: APR 1992
SHEET NO. 67	OF 10 SHEETS

STANDARD PLANS SUMMARY

FED. ROAD DIST. NO.	STATE	FED. AID PROJ. NO.	FISCAL YEAR	SHEET NO.	TOTAL SHEETS
HAWAII	HAW.	I-H3-1(66)	1992	8	440

STANDARD PLAN NO.	TITLE	DATE
B-01	Notes and Miscellaneous Details	07/01/86
B-02		
B-03	Typical Structure Excavation and Backfill Pay Limits	07/01/86
B-04		
B-05		
B-06	Concrete Box Girder	07/01/86
B-07	Concrete Box Girder	07/01/86
B-08	Concrete Box Girder	07/01/86
B-09		
B-10		
B-11		
B-12	Prestressed Concrete Piles	r07/16/90
B-13	Prestressed Concrete Piles	r07/16/90

D-01	Chain Link Fence With Toprail	r03/06/87
D-02	Chain Link Fence Without Toprail	r07/26/90
D-03	Wire Fence With Metal Posts	07/01/86
D-04	Typical Details of Curbs and/or Gutters	07/01/86
D-05	Typical Details of Reinforced Concrete Drop Driveway	07/01/86
D-06	Centerline and Reference Survey Monument	07/01/86
D-07	Street Survey Monument	07/01/86
D-08	Landscaping Shrub and Tree Planting	07/01/86
D-09	Field Office	07/01/86
D-10	Field Office	07/01/86
D-11	Project Site Laboratory	07/01/86
D-12	Project Site Laboratory	07/01/86
D-13	Field Office & Project Site Laboratory	07/01/86

H-01	Type A, B, C and D Catch Basin	07/01/86
H-02	Type A1, B1, C1 and D1 Catch Basin	07/01/86
H-03	Type A2, B2, C2 and D2 Catch Basin	07/01/86
H-04	Typical Reinforcing Details for Catch Basins	07/01/86
H-05	Type A, B and C Storm Drain Manhole	07/01/86
H-06	Type D and E Storm Drain Manhole	07/01/86
H-07	Type F Storm Drain Manhole	07/01/86
H-08	Catch Basin and Manhole Casting	07/01/86
H-09	Type A-9 and A-9P Frames and Grates	07/01/86
H-10	Type A-9B Frames and Grates	07/01/86
H-11	Type 61614 and 61214 Grated Drop Inlet	07/01/86
H-12	Type 61616 Grated Drop Inlet	07/01/86
H-13	61214, 61614 & 61616 Steel Frames and Grates	07/01/86
H-14	61214B Steel Frame and Grates	07/01/86
H-15	61614B Steel Frame and Grates	07/01/86
H-16	Concrete and Cement Rubble Masonry Structures	r10/16/90
H-17	Inlet Structures	r10/16/90
H-18	Flared End Section for Culverts	07/01/86
H-19	Outlet Structures	r02/15/91
H-20	Concrete Spillway Inlet	07/01/86
H-21	18" Slotted C.M.P. Drain	07/01/86
H-22	C.M.P. Coupling Details Standard Joint	r10/16/90
H-23	Hat Shaped Coupling Band	r10/16/90

STANDARD PLAN NO.	TITLE	DATE
TE-01	Miscellaneous Sign Details	07/01/86
TE-02	Galvanized Flanged Channel Sign Post Mounting	07/01/86
TE-03	Galvanized Square Tube Sign Post Mounting	07/01/86
TE-04	Regulatory Signs	r09/01/87
TE-05	Warning Signs	07/01/86
TE-06	Miscellaneous Signs	r11/03/89
TE-07	Reserved	07/01/86
TE-08	Construction Signs	r09/01/87
TE-09	Miscellaneous Intersection Signs	r03/06/87
TE-10	Reserved	07/01/86
TE-11	Bike Route Sign and Supplementary Plates	07/01/86
TE-12	State Route Marker and Auxiliary Markers	07/01/86
TE-13	Interstate Route Marker	07/01/86
TE-14	State Route Marker and Border Detail for Guide Signs	07/01/86
TE-15	Route Marker Assemblies	07/01/86
TE-16	Miscellaneous Reflector Markers	07/01/86
TE-17	Type II Object Markers	07/01/86
TE-18	Mileposts	07/01/86
TE-19	Reserved	07/01/86
TE-20	Overhead Sign Supports	07/01/86
TE-21	Overhead Sign Support, Box Truss Type, Aluminum	07/01/86
TE-22	Foundation Details and Schedules	07/01/86
TE-23	Supports for Ground Mounted Guide Sign	r11/03/89
TE-24	Breakaway Sign Supports for Ground Mounted Guide Signs	07/01/86
TE-25	Laminated Aluminum Sign Panels (Overhead)	07/01/86
TE-26	Laminated Aluminum Sign Panels (Ground Mounted)	07/01/86
TE-27	Solid Aluminum Extruded Sign Panel and Accessory Details	07/01/86
TE-28	Guide Signs Luminaire Mountings	07/01/86
TE-29	Reserved	07/01/86
TE-30	Raised Pavement Markers and Striping	r05/09/90
TE-31	Miscellaneous Pavement Markings	r05/09/90
TE-32	Miscellaneous Pavement Markings	r05/09/90
TE-33	Miscellaneous Pavement Markings	r11/03/89
TE-34	Reserved	07/01/86
TE-35	Pavement Alphabets, Numbers & Symbols	07/01/86
TE-36	Pavement Alphabets, Numbers & Symbols	07/01/86
TE-37	Reserved	07/01/86
TE-38	Traffic Signal System, Miscellaneous Details	r11/03/89
TE-39	Traffic Signal System, Miscellaneous Details	07/01/86
TE-40	Loop Detectors	r11/03/89
TE-41	Pullboxes	07/01/86
TE-42	Type III Traffic Signal Standard	07/01/86
TE-43	Concrete Pullbox (2' x 3')	07/01/86
TE-44	Reserved	07/01/86

STANDARD PLAN NO.	TITLE	DATE
TE-45	Reserved	07/01/86
TE-46	Reserved	07/01/86
TE-47	Reserved	07/01/86
TE-48	Reserved	07/01/86
TE-49	Reserved	07/01/86
TE-50	Metal Guardrail	r03/06/87
TE-51	Metal Guardrail	r09/01/87
TE-52	Metal Guardrail with Rubrail	r11/03/89
TE-53	Metal Guardrail with Rubrail at Obstruction	r09/01/87
TE-54	Beam Type Guardrail with Rubrail at Obstruction (Shoulder Installation)	r11/03/89
TE-55	Metal Guardrail Connection to Concrete Barrier	r11/03/89
TE-56	Concrete Barrier Transition	07/01/86
TE-57	Guardrail Type 3, Thrie Beam	r11/03/89
TE-57A	Guardrail Type 3, Modified Thrie Beam	11/03/89
TE-58	Approach End Flare, One & Two Way Roadway	07/01/86
TE-59	Trailing End Flare, One & Two Way Roadway	r11/03/89
TE-60	Anchor Block Details	07/01/86
TE-61	Breakaway Cable Terminal (BCT)	r11/03/89
TE-62	Breakaway Cable Terminal (BCT)	r09/01/87
TE-63	Guardrail Type 4 (Rigid Barrier)	r09/01/87
TE-64	Portable Concrete Barrier	r11/03/89
TE-65	Guardrail Type 4, Miscellaneous	r09/01/87
TE-66	Barricades	07/01/86
TE-67	Delineation & Pavement Markings at Bridges	07/01/86
TE-68	Wheelchair Ramps	r11/03/89
TE-69	Wheelchair Ramps	r11/03/89

NOTE:
STANDARD PLANS APPLICABLE TO THIS PROJECT ARE INDICATED BY A " ● " NEXT TO THE STANDARD PLAN NO. (D-07 ●)

02/15/91	REVISED STANDARD PLANS H-19
10/16/90	REVISED STANDARD PLANS H-16,H-17, H-22 & H-23.
07/26/90	REVISED STANDARD PLANS D-02.
07/16/90	REVISED STANDARD PLANS B-12,B-13,
05/09/90	REVISED STANDARD PLANS TE-30,TE-31, & TE-32.
11/03/89	REVISED STANDARD PLANS TE-06,TE-23, TE-30, TE-31, TE-32, TE-33, TE-38, TE-40, TE-52, TE-54, TE-55, TE-57, TE-59, TE-61, TE-64, TE-68 & TE-69.
	ADDED TE-57A TO STANDARD PLANS
09/01/87	REVISED STANDARD PLANS TE-04,TE-06, TE-08, TE-32, TE-51, TE-53, TE-54, TE-55, TE-57, TE-59, TE-62, TE-63, TE-65 & TE-69.
03/06/87	REVISED STANDARD PLANS D-01, TE-09, TE-40, TE-50, TE-51, TE-57, TE-59, TE-61, TE-63 & TE-64.
DATE	REVISION



THIS WORK WAS PREPARED BY ME OR UNDER MY SUPERVISION.
William H. Hansler

7/22/92	Revised sheet to 2/15/91 version of Std. Plans. Indicated TE-13 and deleted TE-14.
DATE	REVISION
STATE OF HAWAII DEPARTMENT OF TRANSPORTATION HIGHWAYS DIVISION	
STANDARD PLANS SUMMARY	
GENERAL	
INTERSTATE ROUTE H-3	
F.A.I. PROJECT NO. I-H3-1(66)	
SCALE: NONE	DATE: APR. 1992
SHEET No. G8 OF 10 SHEETS	

SURVEY PLOTTED BY	DATE
DRAWN BY	7/20/92
DESIGNED BY	
CHECKED BY	
QUANTITIES BY	
NOTED BY	
NO.	

ALT.	ALTERNATE	MH.	MANHOLE
ARCH.	ARCHITECTURAL	M.L.	MATCH LINE
A.C., AC	ASPHALT CONCRETE	MIN.	MINIMUM
A.I.S.I.	AMERICAN IRON AND STEEL INSTITUTE	MISC.	MISCELLANEOUS
ASTM	AMERICAN SOCIETY FOR TESTING MATERIAL	MSL	MEAN SEA LEVEL
AZ.	AZIMUTH	N	NORTH
		NIC	NOT IN CONTRACT
BEG.	BEGIN	NO., #	NUMBER
BK.	BACK	NTP	NOTICE TO PROCEED
BOT., BOTT.	BOTTOM	NTS	NOT TO SCALE
B.O.F.	BOTTOM OF FOOTING		
BULKHD.	BULKHEAD	OB	OUTBOUND
		O.C.	ON CENTER
C.B.	CATCH BASIN	O.H.	OPPOSITE HAND
CRM	CEMENT RUBBLE MASONRY	O/H	OVERHEAD
CL	CENTERLINE	O/S	OFFSET
C.J.	CONSTRUCTION JOINT	OPN'G.	OPENING
CL.	CLASS		
CONC.	CONCRETE	PAVT.	PAVEMENT
COND.	CONDUIT	PERF.	PERFORATED
CMP	CORRUGATED METAL PIPE	PC	POINT OF CURVATURE, PRECAST
CF	CUBIC FEET	PCC	POINT OF COMPOUND CURVATURE
CULV.	CULVERT		PORTLAND CEMENT CONCRETE
		PB	PULLBOX
DET.	DETAIL	PL., P	PLATE
D, DIA., Ø	DIAMETER	PROJ.	PROJECT
DIM.	DIMENSION	PT.	POINT
		PVC	POLYVINYL CHLORIDE
E	EAST		
EA.	EACH	R	RADIUS
EASMT.	EASEMENT	RC	REINFORCED CONCRETE
E.P.	EDGE OF PAVEMENT	RCP	REINFORCED CONCRETE PIPE
EL, ELEV.	ELEVATION	RD.	ROAD
ELEC.	ELECTRICAL	REF.	REFERENCE
EMB.	EMBANKMENT	REINF.	REINFORCING
ENG., ENGR.	ENGINEER	REQ., REQ'D.	REQUIRED
EO.	EQUAL	RGS	RIGID GALVANIZED STEEL
EXT.	EXTERIOR	RN	REFERENCE NORTH
		RT.	RIGHT
F.A.I.	FEDERAL AID INTERSTATE	R/W	RIGHT OF WAY
FT., '	FEET, FOOT		
FH	FIRE HYDRANT	S	SOUTH
FW	FIRE WATER LINE	SECT.	SECTION
FWY.	FREEWAY	SF	SQUARE FEET
GALV.	GALVANIZED	SIM.	SIMILAR
GSP	GALVANIZED STEEL PIPE	SHT.	SHEET
GA.	GAUGE, GAGE	SPC.	SPACING
GCL	GRADE CONTROL LINE	STA.	STATION
		STD.	STANDARD
HECO	HAWAII ELECTRIC COMPANY	SY	SQUARE YARDS
HT.	HEIGHT	SYM.	SYMMETRICAL
H.P.	HIGH POINT		
HWY.	HIGHWAY	T&B	TOP AND BOTTOM
HOR., HORIZ.	HORIZONTAL	T.O.C.	TOP OF CONCRETE
HVB	HAIKU VALLEY BRIDGE	THK.	THICK
		TYP.	TYPICAL
IB	INBOUND		
IN., "	INCH	U.N.O.	UNLESS NOTED OTHERWISE
INT.	INTERIOR		
INV.	INVERT	V	VALVE
		VAR.	VARIABLE, VARIES
L.	LENGTH	VENT.	VENTILATION
LF	LINEAR FOOT	VERT.	VERTICAL
LG	LONG		
LIN.	LINEAR	W.	WALL
LT.	LEFT	W	WEST
LTG.	LIGHTING	W.P.	WORK POINT
		WSP	WET STAND PIPE
MAT'L	MATERIAL	WWV	WINDWARD VIADUCT
MAX.	MAXIMUM		
MECH.	MECHANICAL		

SECTION

B

SECTION DESIGNATION

ST2 | ST8

SHEET ON WHICH SECTION IS DRAWN

SHEET FROM WHICH SECTION IS TAKEN

DETAIL

4

DETAIL DESIGNATION

ST2 | ST8

SHEET ON WHICH DETAIL IS DRAWN

SHEET FROM WHICH DETAIL IS TAKEN

C

6

SECTION OR DETAIL TAKEN AND DRAWN ON THE SAME SHEET OR STANDARD SECTIONS OR DETAIL

AS SHOWN

OPPOSITE HAND

SECTION

B

ST2 | ST8

SECTION/O.H.

B

ST2 | ST8

868.00 DENOTES BOTTOM OF FOUNDATION ELEVATION
WITH RESPECT TO DATUM AT MSL.

- (36) DENOTES F.A.I. PROJ. NO. I-H3-1(36)
HAIKU ACCESS ROAD PORTAL DRAINAGE DETAILS
- (37) DENOTES F.A.I. PROJ. NO. I-H3-1(37)
TRANS-KOOLAU EXPLORATORY TUNNEL
- (52) DENOTES F.A.I. PROJ. NO. I-H3-1(52)
HAIKU VALLEY BRIDGES
- (57 & 58) DENOTES F.A.I. PROJ. NO. I-H3-1(57 & 58)
WINDWARD VIADUCT
- (60) DENOTES F.A.I. PROJ. NO. I-H3-1(60)
FURNISHING AND INSTALLATION OF VENTILATION FANS
- (61) DENOTES F.A.I. PROJ. NO. I-H3-1(61)
HAIKU APPROACH AND TUNNELS
- (64) DENOTES F.A.I. PROJ. NO. I-H3-1(64)
HALAWA APPROACH AND TUNNELS
- (65) DENOTES F.A.I. PROJ. NO. I-H3-1(65)
FURNISHING AND INSTALLING SYSTEM COMPONENTS
- (66) DENOTES F.A.I. PROJ. NO. I-H3-1(66)
MECHANICAL, ELECTRICAL AND ARCHITECTURAL FINISH
- (71) DENOTES F.A.I. PROJ. NO. I-H3-1(71)
NORTH HALAWA VALLEY VIADUCT

1. THE ABBREVIATIONS ON THIS PLAN APPLY TO ALL PLANS, UNLESS NOTED OTHERWISE ON THE DISCIPLINE ABBREVIATION PLANS.
2. REFERENCE PLAN CALL OUT EXAMPLE: SHT. NO. H6(52) DENOTES SHEET NO. H6 OF F.A.J. PROJ. NO. I-H3-I(52) HAIKU VALLEY BRIDGES.

FED. ROAD DIST. NO.	STATE	FED. AID PROJ. NO.	FISCAL YEAR	SHEET NO.	TOTAL SHEETS
HAWAII	HAW.	I-H3-1(66)	1992	9	440

ORIGINAL	SURVEY PLOTTED BY	DATE
PLAN	DRAWN BY	7/89
	TRACED BY	
NOTE BOOK	DESIGNED BY	7/89
	QUANTITIES BY	
NO.	CHECKED BY	7/90

DATE	REVISION

STATE OF HAWAII
DEPARTMENT OF TRANSPORTATION
HIGHWAYS DIVISION

ABBREVIATIONS
LEGEND & NOTES
GENERAL
INTERSTATE ROUTE H-3
F.A.I. PROJ. NO. I-H3-I(66)

SCALE: NONE DATE: APR 1992

SHEET NO. G9 OF 10 SHEETS



THIS WORK WAS PREPARED BY ME
OR UNDER MY SUPERVISION

William H. Kamm


FED. ROAD DIST. NO.	STATE	FED. AID PROJ. NO.	FISCAL YEAR	SHEET NO.	TOTAL SHEETS
HAWAII	HAW.	I-H3-1(66)	1992	10	440

LEGEND

(60) : F.A.I. PROJ. NO. (60)

NTP : NOTICE TO PROCEED
5/92 INDICATES PROJECTED DATE
3/18/91 INDICATES ACTUAL OR
CURRENT CONTRACT MILESTONE DATE

61a : ACTIVITY NO.
(SEE PROPOSAL FORM)

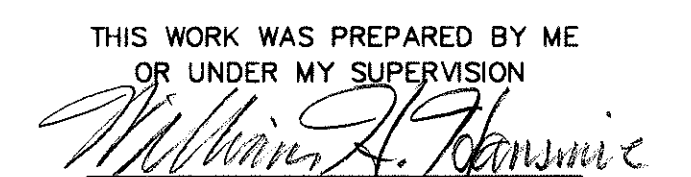

ORIGINAL PLAN	SURVEY PLOTTED BY _____	DATE _____
	DRAWN BY _____	_____
	CADD _____	5/28/92
NOTEBOOK	DESIGNED BY _____	_____
	QUANTITIES BY _____	4/8/92
	CHECKED BY _____	_____
	W. H. HANSMAIRE	5/28/92