

ABBREVIATIONS

ABBR	ABBREVIATION	IB	INBOUND
ABV	ABOVE	IE	INVERT ELEVATION
AC	AIR CONDITIONING UNIT	IN	INCHES
AD	ACCESS DOOR	KW	KILOWATT
AFF	ABOVE FINISH FLOOR	LBS	POUNDS
AH	AIR HANDLING UNIT	MECH	MECHANICAL
AP	ACCESS PANEL	ML	MATCH LINE
ARCH	ARCHITECTURAL	NC	NORMALLY CLOSED
ATM	ATMOSPHERE	NIC	NOT IN CONTRACT
BHP	BRAKE HORSEPOWER	NO	NORMALLY OPEN
BOD	BOTTOM OF DUCT	NTS	NOT TO SCALE
BTUH	BRITISH THERMAL UNITS PER HOUR	OA	OUTSIDE AIR
CFM	CUBIC FEET PER MINUTE	OB	OUTBOUND
CI	CAST IRON	OC	ON CENTER
CLG	CEILING	PD	PRESSURE DROP
CL	CENTERLINE	PL	PLATE
CONN	CONNECTION/CONNECT	POC	POINT OF CONNECTION
CONT	CONTINUATION	PSI	POUNDS PER SQUARE INCH
CP	CONTROL PANEL	PVC	POLYVINYL CHLORIDE
CU	CONDENSING UNIT	RA	RETURN AIR
dB	DECIBEL	RAD	RETURN AIR DAMPER
DB	DRY BULB	RF	RETURN FAN
DIA	DIAMETER	RM	ROOM
DIM	DIMENSION	RPM	REVOLUTIONS PER MINUTE
DL	DOOR LOUVER	SA	SUPPLY AIR
DN	DOWN	SAT	SOUND ATTENUATOR
DWG	DRAWING	SF	SUPPLY FAN
DX	DIRECT EXPANSION	SP	STATIC PRESSURE
EA	EXHAUST AIR	STD	STANDARD
EF	EXHAUST FAN	STRUCT	STRUCTURAL
ELEC	ELECTRICAL	STL	STEEL
ELEV	ELEVATION	SS	SERVICE SINK
EQUIP	EQUIPMENT	TEMP	TEMPERATURE
EXH	EXHAUST	TG	TRANSFER GRILL
F	DEGREES FAHRENHEIT	TP	TOTAL PRESSURE
FHC	FIRE HOSE CABINET	TYP	TYPICAL
FLR	FLOOR	V	VENT
FIN	FINISHED	VT	VENT TERMINATION
FT	FEET	VTR	VENT THROUGH ROOF
GA	GAUGE	WB	WET BULB
GALV	GALVANIZED	WG	WATER GAUGE
GPM	GALLONS PER MINUTE	W/O	WITHOUT
HP	HORSE POWER		
Hz	HERTZ		

SYMBOLS

	CEILING SUPPLY DIFFUSER
	WALL SUPPLY REGISTER
	RETURN AIR/EXHAUST AIR REGISTER (RG/EG-RETURN AIR/EXHAUST AIR GRILLS)
	ELBOW WITH TURNING VANES
	FLEXIBLE CONNECTION
	ELECTRIC DUCT HEATER
	SUPPLY AIR DUCT SECTION
	RETURN AIR/EXHAUST AIR DUCT SECTION
	RECTANGULAR-ROUND TRANSITION
	SOUND ATTENUATOR
	INTERNAL INSULATION
	EXTERNAL INSULATION
	AIR EXTRACTOR
	DUCT RISE IN DIRECTION OF AIR FLOW
	DUCT DROP IN DIRECTION OF AIR FLOW
	FIRE DAMPER AND SLEEVE WITH ACCESS DOOR
	SMOKE DAMPER WITH ACCESS DOOR
	BACKDRAFT DAMPER
	MANUAL VOLUME DAMPER
	MOTOR OPERATED DAMPER (MOD)
	DOOR LOUVER (DL) (SEE ARCH. DWGS. FOR SIZE)
	WALL/PARTITION LOUVER (SEE ARCH. DWGS. FOR SIZE)
	SUPPLY AIR FLOW
	RETURN/EXHAUST AIR FLOW
	THERMOSTAT
	HUMIDISTAT
	FAN, CENTRIFUGAL
	FAN, PROPELLER
	ROOF VENTILATOR, INTAKE
	ROOF VENTILATOR, EXHAUST
	ROOF VENTILATOR, LOUVERED
	EQUIPMENT IDENTIFICATION TAG

FED. ROAD DIST. NO.	STATE	FED. AID PROJ. NO.	FISCAL YEAR	SHEET NO.	TOTAL SHEETS
HAWAII	HAW.	I-H3-I(66)	1992	11	440

GENERAL NOTES

I. SYMBOLS AND ABBREVIATIONS SHOWN ON THIS SHEET INCLUDE ITEMS WHICH MAY NOT BE PRESENTLY PART OF THIS CONTRACT.

[illegible]

STATE OF HAWAII
DEPARTMENT OF TRANSPORTATION
HIGHWAYS DIVISION

HVAC-LEGEND. SYMB.,

ABBR. & GEN. NOTES

STANDARDS

INTERSTATE ROUTE H-3

F.A.I. PROJ. NO. I-H3-1(66)

SCALE: NONE DATE: APR 1992
SHEET NO. MI OF 28 SHEETS



THIS WORK WAS PREPARED BY ME
OR UNDER MY SUPERVISION

John Doe

ABBREVIATIONS

ABBR	ABBREVIATION	OB	OUTBOUND
ABV	ABOVE	OC	ON CENTER
ASSY	ASSEMBLY	PDI	PLUMBING DRAINAGE INSTITUTE
ARCH	ARCHITECTURAL	PL	PLATE
BHP	BRAKE HORSE POWER	POC	POINT OF CONNECTION
BOP	BOTTOM OF PIPE	PSI	POUNDS PER SQUARE INCH
CI	CAST IRON	PVC	POLYVINYL CHLORIDE
CLG	CEILING	REQ'D	REQUIRED
CL	CENTERLINE	RM	ROOM
CONN	CONNECTION/CONNECT	RPM	REVOLUTIONS PER MINUTE
CONT	CONTINUATION	SPEC	SPECIFICATION
DET	DETAIL	STD	STANDARD
DIA	DIAMETER	STRUCT	STRUCTURAL
DN	DOWN	STL	STEEL
DWG	DRAWING	TEMP	TEMPERATURE
ELEC	ELECTRICAL	TP	TRAP PRIMER
ELEV	ELEVATOR	TYP	TYPICAL
F	DEGREES FAHRENHEIT	VB	VALVE BOX
FHC	FIRE HOSE CABINET	VS	VALVE STATION
FLEX	FLEXIBLE	VT	VENT TERMINATION
FLR	FLOOR	WH	WATER HEATER
FIN	FINISHED	FW	FIRE WATER
FP	FIRE PROTECTION	WSP	WET STAND PIPE
FT	FEET	FH	FIRE HYDRANT
GALV	GALVANIZED	CP	CROSSPASSAGE
GPM	GALLONS PER MINUTE	D.I.	DUCTILE IRON
HP	HORSE POWER	V	VENT (SANITARY)
HZ	HERTZ	VTR	VENT THRU ROOF
IB	INBOUND		
IE	INVERT ELEVATION		
IN	INCHES		
KW	KILOWATT		
MAX	MAXIMUM		
MECH	MECHANICAL		
MIN	MINIMUM		
NC	NORMALLY CLOSED		
NIC	NOT IN CONTRACT		
NO	NORMALLY OPEN		
NPT	NATIONAL PIPE THREAD		
NTS	NOT TO SCALE		

PIPING

FIRE PROTECTION AND DOMESTIC WATER

—CW—	DOMESTIC COLD WATER	—SD—	STORM DRAIN
—FW—	FIRE WATER	—V—	VENT
—WSP—	WET STANDPIPE	—S—	SANITARY SEWER
—TW—	TRUCK WASH	—DD—	DUCT DRAIN
—D—	DRAINAGE	—OD—	OVERFLOW DRAIN

FITTINGS

PLAN	PIPE UP	PIPE DOWN	
			ELBOW - 90° SHORT RADIUS
			ELBOW - 90° LONG RADIUS
			ELBOW - 45°
			TEE

SYMBOLS

SYMBOL	ABBR.	DESCRIPTION
		UNION
		FLANGED JOINT
	EJ	EXPANSION JOINT
		CAP ON END OF PIPE
		DIRECTION OF SLOPE
		THERMOMETER w/SEP. SOCKET WELL
		PRESSURE GAUGE w/PET COCK
		PUMP
		STRAINER
		REDUCER - ECCENTRIC DOWN
		REDUCER - CONCENTRIC
		REDUCER - ECCENTRIC UP
	FD	FLOOR DRAIN
	FS	FLOOR SINK
	RD	ROOF DRAIN
	OD	OVERFLOW DRAIN
	AD	AREA DRAIN
	FCO	FLOOR CLEANOUT
	GCO	GRADE CLEANOUT
	PLD	PLANTER DRAIN
	WCO	WALL CLEANOUT
	BFP	BACKFLOW PREVENTOR (INDICATE TYPE)
	AVB	ATMOSPHERIC VACUUM BREAKER
	GV	GATE VALVE
	GLV	GLOBE VALVE
	CV	CHECK VALVE
	HB	HOSE BIBB
	PSV	PRESSURE SAFETY VALVE
	BV	BUTTERFLY VALVE
		AIR RELIEF AND VACUUM RELIEF VALVE
	PRV	PRESSURE REGULATOR VALVE
	TPV	TRAP PRIMER VALVE
	WHA	WATER HAMMER ARRESTER, PDI AS SHOWN
		EQUIPMENT IDENTIFICATION TAG
	FDC	ROOF FIRE DEPARTMENT OUTLET CONNECTION
	FH	FIRE HYDRANT

PLUMBING FIXTURES

SYMBOL	ABBR.	
	WC	WATER CLOSET
	UR	URINAL
	LAV	LAVATORY
	SS	SERVICE SINK
	BS	BATTERY SINK
	KS	KITCHEN SINK
	EW C	ELECTRIC WATER COOLER
	ES	EMERGENCY SHOWER & EYE-WASH

FIRE PROTECTION EQUIPMENT

	E1	FIRE EXTINGUISHER - ABC
	E2	FIRE EXTINGUISHER - HALON
	FHC-S	FIRE HOSE CABINET - SURFACE MOUNTED
	FHC-R	FIRE HOSE CABINET - RECESSED
		FIRE HOSE VALVE
	COMB. FHC	COMBINATION FIRE HOSE CABINET


CONTROLS AND INSTRUMENTATION

	FS	FLOW SWITCH
	FE	FLOW ELEMENT
	FQI	FLOW INDICATOR (TOTALIZER)
	ZS	POSITION SWITCH
	PSV	PRESSURE SAFETY VALVE
	PS	PRESSURE SWITCH
	HS HOA	HAND SWITCH - HAND/OFF/AUTO
	PI	PRESSURE INDICATOR
	LALL	LEVEL ALARM - LOW LOW
	LSL	LEVEL SWITCH - LOW
	LSH	LEVEL SWITCH - HIGH
	LAH	LEVEL ALARM - HIGH
	IV	ISOLATION VALVE
	LCP	LOCAL CONTROL PANEL

FED. ROAD DIST. NO.	STATE	FED. AID PROJ. NO.	FISCAL YEAR	SHEET NO.	TOTAL SHEETS
HAWAII	HAW.	I-H3-I(66)	1992	12	440

GENERAL NOTES

1. SYMBOLS AND ABBREVIATIONS SHOWN ON THIS SHEET INCLUDE ITEMS WHICH MAY NOT BE PRESENTLY PART OF THIS CONTRACT.
2. ALL DRAINAGE LINES SHALL BE AT 1% MINIMUM SLOPE UNLESS OTHERWISE NOTED
3. ALL SANITARY LINES SHALL BE AT 2% MINIMUM SLOPE UNLESS OTHERWISE NOTED.
4. FOR BACKGROUND INFORMATION SEE ARCHITECTURAL AND STRUCTURAL PLANS.

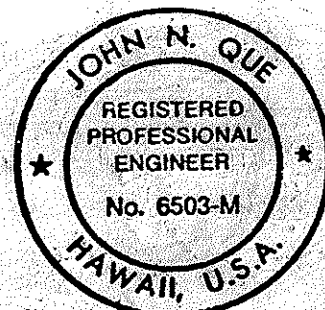

THIS WORK WAS PREPARED BY ME OR UNDER MY SUPERVISION

DATE	REVISION
STATE OF HAWAII DEPARTMENT OF TRANSPORTATION HIGHWAYS DIVISION PLUMBING-LEGEND. SYMB., ABBR. & GEN. NOTES STANDARDS INTERSTATE ROUTE H-3 F.A.I. PROJ. NO. I-H3-I(66) SCALE: NONE DATE: APR 1992 SHEET NO. M2 OF 28 SHEETS	

FED. ROAD DIST. NO.	STATE	FED. AID PROJ. NO.	FISCAL YEAR	SHEET NO.	TOTAL SHEETS
HAWAII	HAW.	I-H3-1(66)	1992	13	440

BUILDING AIR CONDITIONING UNIT SCHEDULE

ABBREVIATIONS: ACFM ACTUAL CUBIC FEET PER MINUTE AR ARRANGEMENT DIM DIMENSION EAT ENTERING AIR TEMPERATURE FDB °F DRY BULB FWB °F WET BULB MAX MAXIMUM OV OUTLET VELOCITY SP STATIC PRESSURE
APD AIR PRESSURE DROP ATM ATMOSPHERIC DWDI DOUBLE WIDTH, DOUBLE INLET EFF EFFICIENCY HP HORSEPOWER MBH 1000 BTU/HR PRESS PRESSURE TOT TOTAL
BI BACKWARD INCLINED DX DIRECT EXPANSION ESP EXTERNAL STATIC PRESSURE FPM FEET PER MINUTE LAT LEAVING AIR TEMPERATURE IN INCHES RPM REVOLUTIONS PER MINUTE TOT TOTAL VEL VELOCITY

EQUIPMENT NO.	AREA SERVED	DRAW-THRU	MULTI-ZONE	AR		SECTIONS								FAN								COOLING COIL (FOR HEATING COIL SEE SCHEDULE THIS SHT.)														FILTER				ISOLATORS		REMARKS				
						COIL				FILTER				WHEEL			PERFORMANCE			MOTOR		HEAT TRANSFER MBH	MAX. FACE VEL. FPM	AIR SIDE				REFRIG. SIDE		DIM.		NO. ROWS	TYPE	MAX FACE VEL FPM	NO. AND SIZE	ATM DUST SPOT EFF (%)	STATIC DEFLECTION IN	SUPPORT FROM	WEIGHT LBS							
																								EAT		LAT		MAX APD IN WG	TYPE	SUCTION °F	LIQUID °F									FIN WIDTH IN	FIN LENGTH IN					
				CH	HW	DX	ELECTRIC	FLAT	ANGLE	COMBINATION	MIXING BOX	NUMBER	DIAMETER (INCHES)	TYPE	RPM	AIR CAPACITY	OUTLET VEL. FPM	ESP	TOT	NAME PLATE HP	RPM			RATED VOLTS/PH/HZ	FDB	FWB	FDB																FWB	TYPE	SUCTION °F	LIQUID °F
				AC-10	CONTROL BUILDING	●	—	●	—	—	—	●	—	●	—	—	●	1	12.25	DWDI BI	2665			2800	1800	—	3.5	3	1800	460/3/60	132.0									420 2800	80.8		67.8	53.4	52.4	0.83
AC-11	HAIKU 1B O & M OFFICE	●	—	●	—	—	—	●	—	●	—	—	●	1				4000			1.0	2		460/3/60	92.0	420 4000	80.8	67.8	53.4	52.4	0.83	22	45	—	—	—		DISPOSABLE	500		77	—	—	450		

CONDENSING UNIT SCHEDULE

ABBREVIATIONS: CAP. CAPACITY HP HORSEPOWER QTY QUANTITY
RPM REVOLUTIONS PER MINUTE REQD REQUIRED

EQUIPMENT NO.	UNIT SERVED	COOLING CAP.	CONDENSER						COMPRESSOR					WEIGHT LBS
			FAN		FAN MOTOR				QTY REQD	HP RPM	VOLTS	PHASE	HERTZ	
			QTY REQD	RPM	HP	VOLTS	PHASE	HERTZ						
CU-1	AC-1		2	1075	1/4	460	3	60	—	— —	—	—	—	170
CU-2	AC-2		2	1075	1/4	460	3	60	—	— —	—	—	—	170
CU-3	AC-3		2	1075	1/2	460	3	60	—	— —	—	—	—	300
CU-4	AC-4		2	1075	1/2	460	3	60	—	— —	—	—	—	300
CU-5	AC-10		2	1100	1	460	3	60	ONE	10 1750	460	3	60	1040
CU-6	AC-11		2		1/2	460	3	60	ONE	15 —	460	3	60	700

ELECTRIC HEATING COIL


ABBREVIATIONS: ACFM ACTUAL CUBIC FEET PER MINUTE LAT LEAVING AIR TEMPERATURE
APD AIR PRESSURE DROP MAX MAXIMUM
EAT ENTERING AIR TEMPERATURE VEL VELOCITY
FPM FEET PER MINUTE

EQUIPMENT NO.	UNIT SERVED	HEAT TRANSFER KW	FACE VEL FPM	AIR SIDE			VOLTS	PHASE	HERTZ	REMARKS
				EAT °F	LAT °F	MAX APD IN WG				
			ACFM							
EH-1	AC-10	12	466 2800	67	80	0.05	460	3	60	—
EH-2	AC-11	15	466 4000	67	80	0.20	460	3	60	—

- NOTES:
1. STATIC PRESSURE IS IN INCHES WATER COLUMN.
 2. ALL FAN HOUSINGS SHALL BE PROTECTED INTERNALLY AND EXTERNALLY WITH CORROSION-RESISTANT FACTORY-APPLIED COATING AS SPECIFIED.

FOR DETAIL AS-BUILT INFORMATION
REFER TO CONSTRUCTION SUBMITTALS

ORIGINAL PLAN
DATE: 9/08/88
DRAWN BY: D. E. DRYDEN
TRACED BY: A. H. PORTIER
NOTE BOOK
QUANTITIES BY: J. N. QUE
CHECKED BY: J. N. QUE
6/7/90

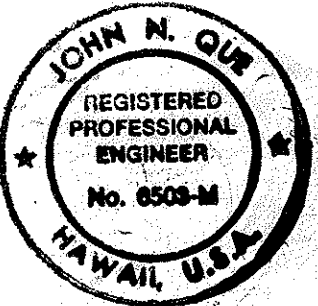

THIS WORK WAS PREPARED BY ME
OR UNDER MY SUPERVISION

John M. Que

7/22/92	ADDENDUM 1-ADDED AC-11, CU-6, EH-2
DATE	REVISION
STATE OF HAWAII DEPARTMENT OF TRANSPORTATION HIGHWAYS DIVISION HVAC EQUIPMENT SCHEDULES 1 STANDARDS INTERSTATE ROUTE H-3 F.A.I. PROJ. NO. I-H3-1(66) SCALE: NONE DATE: APR 1992 SHEET NO. M3 OF 28 SHEETS	

FED. ROAD DIST. NO.	STATE	FED. AID PROJ. NO.	FISCAL YEAR	SHEET NO.	TOTAL SHEETS
HAWAII	HAW.	I-H3-1(66)	1992	14	440

ENVIRONMENTAL AIR CONDITIONING UNIT SCHEDULE

ABBREVIATIONS:


ATM ATMOSPHERIC
CFM CUBIC FEET PER MINUTE
DX DIRECT EXPANSION
EAT ENTERING AIR TEMPERATURE
EXT EXTERNAL
FDB °F DRY BULB
FPM FEET PER MINUTE
FWB °F WET BULB
LAT LEAVING AIR TEMPERATURE
SP STATIC PRESSURE
VEL VELOCITY
QTY QUANTITY
REQD REQUIRED

EQUIPMENT NO.	AREA SERVED	TOTAL COOLING CAPACITY TONS	FAN			COIL							HEATER		HUMIDIFIER		FILTER				RATED VOLTS/PH/HZ	WEIGHT LBS	REMARKS
			AIR FLOW CFM	EXT SP IN. WG	MOTOR HP	TYPE	EAT		LAT				QTY REQD	KW	KW	LBS. VAPOR PER HR.	TYPE	MAX. FACE VEL. FPM	NO. AND SIZE	ATM. DUST SPOT EFF.			
							FDB	FWB	FDB	FWB													
AC-1	CONTROL CENTER	3	1650	0.5	1—¾	DX	72	60	52	50	—	—	ONE	6	2.8	8	DISPOSABLE	300	2 — 16x25x2	50%	460/3/60	625	DOWNFLOW
AC-2	CONTROL CENTER	3	1650	0.5	1—¾	DX	72	60	52	50	—	—	ONE	6	2.8	8	DISPOSABLE	300	2— 16x25x2	50%	460/3/60	625	DOWNFLOW
AC-3	SYSTEMS EQUIPMENT ROOM	8	4400	0.5	2—1	DX	72	60	52	50	—	—	2	6	4	12½	DISPOSABLE	300	4— 16x25x2	50%	460/3/60	1270	UPFLOW
AC-4	SYSTEMS EQUIPMENT ROOM	8	4400	0.5	2—1	DX	72	60	52	50	—	—	2	6	4	12½	DISPOSABLE	300	4— 16x25x2	50%	460/3/60	1270	UPFLOW

NOTES:

1. DELETED.
2. ALL FAN HOUSINGS SHALL BE PROTECTED INTERNALLY AND EXTERNALLY WITH CORROSION-RESISTANT, FACTORY-APPLIED COATING AS SPECIFIED.
3. STATIC PRESSURE IS IN INCHES WATER COLUMN.

ORIGINAL PLAN	DATE	9/07/89
DESIGNED BY	DATE	7/11/89
TRACED BY	DATE	5/07/90
NOTED BY	DATE	
CHECKED BY	DATE	

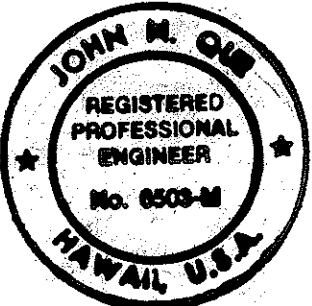

THIS WORK WAS PREPARED BY ME OR UNDER MY SUPERVISION

3/3/94	DELETED THROUGH-WALL SCHEDULE AND NOTE 1 PER DCN 66-037
DATE	REVISION
STATE OF HAWAII DEPARTMENT OF TRANSPORTATION HIGHWAYS DIVISION HVAC-EQUIPMENT SCHEDULES 2 STANDARDS INTERSTATE ROUTE H-3 F.A.I. PROJ. NO. I-H3-1(66) SCALE: NONE DATE: APR 1992 SHEET NO. M4 OF 28 SHEETS	

ORIGINAL PLAN
DATE 9/06/89
DRAWN BY D. E. DRYDEN
TRACED BY A. H. PORTIER
NOTE BOOK
DESIGNED BY A. H. PORTIER
QUANTITIES BY J. N. QUE
CHECKED BY J. N. QUE
5/07/90

FAN SCHEDULE


EQUIPMENT NO.	SERVICE	ARRANGEMENT	CLASS	DRIVE	WHEEL			PERFORMANCE			MOTOR					ISOLATOR BASE		REMARKS
					DIAMETER (INCHES)	TYPE	RPM	AIR CAPACITY	TIP SPEED FPM	STATIC H ₂ O PRESS. IN.	NAME PLATE HP	RPM	VOLTS	PHASE	HERTZ	TYPE	STATIC DEFLEC. IN.	
								ACFM										
EF-1	NOT USED																	
EF-2	CONTROL BUILDING — TOILET RMS. AND JANITOR'S CLOSET	-	-	BELT	8.25	CENTRIFUGAL	1160	550	2505	0.375	¼	1800	115	1	60			UTILITY FAN
EF-3	CONTROL BUILDING ELECTRICAL/MECHANICAL SHOP			BELT	8.25	CENTRIFUGAL	1160	800	2505	0.375	¼	1800	115	1	60			UTILITY FAN
EF-4	CONTROL BUILDING BATTERY ROOM	-	-	BELT	6.75	CENTRIFUGAL	1180	250	2085	0.375	⅛	1800	115	1	60			UTILITY FAN
EF-5	CONTROL BUILDING ELEVATOR MACHINE ROOM	-	-	BELT	6.75	CENTRIFUGAL	1180	130	2085	0.375	⅛	1800	115	1	60			UTILITY FAN
EF-6	CONTROL BUILDING — CONTROL CENTER & SYSTEMS EQUIPMENT ROOM CLEAN AGENT AUTOMATIC FIRE SUPPRESSION SYSTEM EXHAUST	-	-	BELT	12.25	CENTRIFUGAL	613	1400	1965	0.375	⅓	1800	115	1	60			UTILITY FAN
EF-7	CONTROL BUILDING UPS	-	-	BELT	9.75	CENTRIFUGAL	830	800	2120	0.375	¼	1800	115	1	60			UTILITY FAN
EF-8	NOT USED																	
EF-9	HALAWA OB TOILET ROOM — LEVEL 2	-	-	BELT	6.25	CENTRIFUGAL	1220	350	2010	0.375	⅛	1800	115	1	60			CEILING FAN
EF-10	DELETED																	
EF-11	HALAWA IB PUMP ROOM — LEVEL 2	-	-	BELT	8.0	CENTRIFUGAL	1125	890	2360	0.375	¼	1800	115	1	60			CABINET FAN
EF-12	HALAWA IB TOILET ROOM — LEVEL 2	-	-	BELT	5.25	CENTRIFUGAL	1220	170	1680	0.25	⅓	1800	115	1	60			CEILING FAN
EF-13	DELETED																	
EF-14	HAIKU OB TOILET ROOM — LEVEL A	-	-	BELT	5.25	CENTRIFUGAL	1220	170	1680	0.25	⅓	1800	115	1	60			CEILING FAN
EF-15	DELETED																	
EF-16	DELETED																	
EF-17	HAIKU OB PUMP ROOM — LEVEL A	-	-	BELT	8.0	CENTRIFUGAL	1125	890	2360	0.375	¼	1800	115	1	60			CABINET FAN
EF-18	HAIKU OB STORAGE ROOM — LEVEL A	-	-	BELT	7.30	CENTRIFUGAL	1245	660	2380	0.375	¼	1800	115	1	60			IN LINE FAN
EF-19	HAIKU IB TOILET ROOM — LEVEL A	-	-	BELT	5.25	CENTRIFUGAL	1515	270	2080	0.25	⅛	1800	115	1	60			CEILING FAN
EF-20	DELETED																	
EF-21	DELETED																	
EF-22	HAIKU IB STORAGE ROOM — LEVEL A	-	-	BELT	7.30	CENTRIFUGAL	1245	660	2380	0.375	¼	1800	115	1	60			IN LINE FAN
EF-35,36,37	HAIKU IB GARAGE	-	-	BELT	9.75	CENTRIFUGAL	830	800	2120	0.375	¼	1800	115	1	60			ROOF FAN
SF-1,2,3,4	HALAWA OB,IB - HAIKU OB,IB - MCC ROOM VENTILATION	-	-	BELT	36.0	PROPELLER	—	10,000	—	ATMOS	1	—	460	3	60			WALL FAN W/MANUAL BACKDRAFT DAMPER
AH-3	HALAWA OB MCC, SWITCHGEAR ROOM AND LEVEL 4	-	-	BELT	22.25	CENTRIFUGAL	530	9850	3110	1.5	5	1800	460	3	60			CABINET FAN
AH-4	HALAWA IB MCC, SWITCHGEAR ROOM AND LEVEL 4	-	-	BELT	22.25	CENTRIFUGAL	535	10150	3115	1.5	5	1800	460	3	60			CABINET FAN
AH-5	HAIKU OB MCC, SWITCHGEAR ROOM AND LEVEL 4	-	-	BELT	22.25	CENTRIFUGAL	530	8900	3075	1.5	5	1800	460	3	60			CABINET FAN
AH-6	HAIKU IB MCC, SWITCHGEAR ROOM AND LEVEL 4	-	-	BELT	22.25	CENTRIFUGAL	530	9100	3080	1.5	5	1800	460	3	60			CABINET FAN
EF-23	CROSSPASSAGE NO. 1 ATS AND TRANSFORMER ROOM	-	-	BELT	18.25	CENTRIFUGAL	1394	1800	—	0.25	½	1527	115	1	60			IN LINE FAN
EF-24	CROSSPASSAGE NO. 3 ATS AND TRANSFORMER ROOM	-	-	BELT	18.25	CENTRIFUGAL	1394	1800	—	0.25	½	1527	115	1	60			IN LINE FAN
EF-25	CROSSPASSAGE NO. 5 ATS AND TRANSFORMER ROOM	-	-	BELT	18.25	CENTRIFUGAL	1394	1800	—	0.25	½	1527	115	1	60			IN LINE FAN
EF-26	CROSSPASSAGE NO. 7 ATS AND TRANSFORMER ROOM	-	-	BELT	18.25	CENTRIFUGAL	1394	1800	—	0.25	½	1527	115	1	60			IN LINE FAN
EF-27	CROSSPASSAGE NO. 9 ATS AND TRANSFORMER ROOM	-	-	BELT	18.25	CENTRIFUGAL	1394	1800	—	0.25	½	1527	115	1	60			IN LINE FAN
EF-28,-29,-30	CONTROL BUILDING GARAGE	-	-	BELT	9.75	CENTRIFUGAL	830	800	2120	0.375	¼	1800	115	1	60			ROOF FAN
EF-31,-32,-33,-34	CONTROL BUILDING EMERGENCY GENERATOR ROOM	-	-	BELT	33.0	CENTRIFUGAL	200	8000	1730	0.375	2	1800	460	3	60			ROOF FAN
EF-38,39,40,-41	HAIKU IB SHOP	-	-	BELT	9.75	CENTRIFUGAL	930	900	2385	0.375	¼	1800	115	1	60			ROOF FAN
EF-42	HAIKU IB TOILET/SHOWER	-	-	BELT	9.75	CENTRIFUGAL	830	800	2120	0.375	¼	1800	115	1	60			ROOF FAN

FED. ROAD DIST. NO.	STATE	FED. AID PROJ. NO.	FISCAL YEAR	SHEET NO.	TOTAL SHEETS
HAWAII	HAW.	I-H3-1(66)	1992	15	440

NOTES:

- ADJUSTABLE MOTOR SHEAVE IF MOTOR IS 10 HP OR LESS. RAIL VIBRATION BASE WITH SLIDING MOTOR MOUNT.
- BATTERY ROOM EXHAUST FAN (EF-4) SHALL BE SPARK PROOF.
- ALL FAN HOUSINGS SHALL BE PROTECTED INTERNALLY AND EXTERNALLY WITH CORROSION-RESISTANT FACTORY-APPLIED COATING AS SPECIFIED.

9/15/94	DELETED EF-10, EF-13, EF-15, EF-16, EF-20 AND EF-21 PER DCN 66-052
3/7/94	ADDED SF-1, 2, 3, 4 PER DCN 66-039
3/3/94	REVISED EF-23, 24, 25, 26, 27 DATA PER DCN 66-037
1/25/94	REV. EF-6 SERVICE DESCRIPTION PER DCN 66-034
1/22/92	APPENDUM 1 - ADDED EF-39 THRU 42
DATE	REVISION

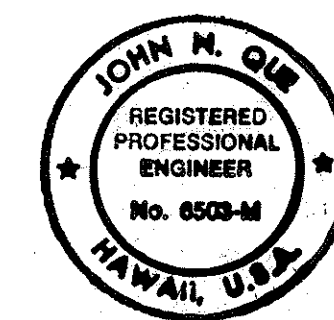


THIS WORK WAS PREPARED BY ME OR UNDER MY SUPERVISION

STATE OF HAWAII
DEPARTMENT OF TRANSPORTATION
HIGHWAYS DIVISION
HVAC-EQUIPMENT
SCHEDULES 3
STANDARDS
INTERSTATE ROUTE H-3
F.A.I. PROJ. NO. I-H3-1(66)

SCALE: NONE DATE: APR 1992
SHEET NO. M5 OF 28 SHEETS

FED. ROAD DIST. NO.	STATE	FED. AID PROJ. NO.	FISCAL YEAR	SHEET NO.	TOTAL SHEETS
HAWAII	HAW.	I-H3-1(66)	1992	16	440

AIR DISTRIBUTION DEVICE SCHEDULE							
EQUIP.	DESCRIPTION		REMARKS	EQUIP.	DESCRIPTION		REMARKS
CSD-1	CEILING DIFFUSER	FOR EXPOSED CEILING	CEILING DIFFUSER W/ OPPOSED BLADE DAMPER, LOUVERED FACE - FIXED LOUVERS SIZE 24" x 24" FLOW PATTERN AS INDICATED NECK SIZE AS INDICATED	CRR-1	CEILING RETURN REGISTER	EXPOSED CEILING	CEILING RETURN GRILLE W/ OPPOSED BLADE DAMPER, LOUVERED FACE FIXED LOUVERS SIZE 24" x 24" DUCT SIZE AS INDICATED
CSD-2	CEILING DIFFUSER	FOR SUSPENDED CEILING	PERFORATED CEILING DIFFUSER W/ OPPOSED BLADE DAMPER, FLUSH FACE MODULE SIZE 24" x 24" NECK SIZE AS INDICATED	CRR-2	CEILING RETURN REGISTER	SUSPENDED CEILING	PERFORATED RETURN W/ OPPOSED BLADE DAMPER, FLUSH FACE MODULE SIZE 24" x 24" NECK SIZE AS INDICATED
WSR-1	SIDEWALL DIFFUSER	TYPE DOUBLE DEFLECTION	FRONT BLADES // TO LONG DIMENSION REAR BLADES // TO SHORT DIMENSION ALL BLADES INDIVIDUALLY ADJUSTABLE 3/4" BLADE SPACING DUCT SIZE AS INDICATED	CEG-1	CEILING EXHAUST GRILLE	EXPOSED CEILING	CEILING RETURN GRILLE W/ OPPOSED BLADE DAMPER, LOUVERED FACE FIXED DEFLECTION - 1/2" SPACING SIZE 24" x 24" DUCT SIZE AS INDICATED
DSR-1	DUCT SUPPLY REGISTER	TYPE DOUBLE DEFLECTION	FRONT BLADES // TO LONG DIMENSION REAR BLADES // TO SHORT DIMENSION ALL BLADES INDIVIDUALLY ADJUSTABLE 3/4" BLADE SPACING DUCT SIZE AS INDICATED	WRR-1	WALL RETURN REGISTER	TYPE ZERO FIXED DEFLECTION	ONE SET OF FIXED BLADES // TO LONG DIMENSION, 1/2" BLADE SPACING OPPOSED BLADE DAMPER DUCT SIZE AS INDICATED
DRR-1	DUCT RETURN REGISTER	TYPE ZERO FIXED DEFLECTION	ONE SET OF BLADES // TO LONG DIMENSION, 1/2" BLADE SPACING OPPOSED BLADE DAMPER DUCT SIZE AS INDICATED	CSD-3	CEILING DIFFUSER	FOR GYPSUM BOARD CEILING	PERFORATED CEILING DIFFUSER W/ OPPOSED BLADE DAMPER, FLUSH FACE MODULE SIZE 24" x 24" FLOW PATTERN AS INDICATED NECK SIZE AS INDICATED
FSR-1	FLOOR SUPPLY REGISTER	TYPE FIXED GRID	EGGCRATE RETURN GRILLE 1/2" x 1/2" x 1" GRID DUCT SIZE AS INDICATED	CRR-3	CEILING RETURN REGISTER	GYPSUM BOARD CEILING	PERFORATED RETURN W/ OPPOSED BLADE DAMPER, FLUSH FACE MODULE SIZE 24" x 24" NECK SIZE AS INDICATED

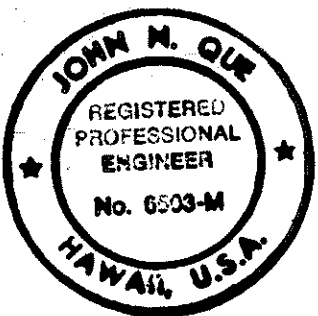

THIS WORK WAS PREPARED BY ME
OR UNDER MY SUPERVISION

DATE	REVISION

STATE OF HAWAII
DEPARTMENT OF TRANSPORTATION
HIGHWAYS DIVISION

HVAC EQUIPMENT
SCHEDULES 4
STANDARDS
INTERSTATE ROUTE H-3
F.A.I. PROJ. NO. I-H3-1(66)

SCALE: NONE DATE: APR 1992

SHEET NO. M6 OF 28 SHEETS


ORIGINAL PLAN	SURVEY PLOTTED BY B. BUNYI	DATE 11/22/89
NOTE BOOK NO.	DESIGNED BY A. H. PORTER	11/13/89
	QUANTITIES BY J. N. QUE	5/05/90
	CHECKED BY	

FED. ROAD DIST. NO.	STATE	FED. AID PROJ. NO.	FISCAL YEAR	SHEET NO.	TOTAL SHEETS
HAWAII	HAW.	I-H3-1(66)	1992	17	440

		PUMP SCHEDULE																																							
ABBREVIATIONS: EFF - MINIMUM ACCEPTABLE EFFICIENCY, TDH - TOTAL DYNAMIC HEAD		NOTE: HEAD IN FEET OF PUMPED FLUID																																							
EQUIPMENT NUMBER	SERVICE	SUCTION RATINGS				MOTOR								FLUID PUMPED				CONNECTIONS					TYPE									REMARKS									
		NET POS FT	SUC LIFT FT	FLOW, GPM	TDH ft.	MIN. EF., %	POWER REQ'D, BHP	NAME PLATE, HP	RPM	VOLTS	PHASE	HERTZ	INDOORS	OUTDOORS	TEMP		WATER	OTHER		TEMP		FLANGED	SCREWED	SWEAT	RATING	CPSI			DUPLEX SUBMERGE	STAGES	HORIZONTAL		VERTICAL	SPLIT CASE	END SECTION	CLOSE COUPLE	GEAR TYPE				
															MIN. °F	MA° XF		FLUID	SPECIFIC GRAVITY	MIN. °F	MAX °F																				
FP-MN01	FIRE PROTECTION	—	—	1000	215	—	—	100	1,760	460	3	60	•	—	50	104	•	—	1.0	40	85	•	—	—	—	—	—			—	1	•	—	•	—	—	—			HALAWA PORTAL BUILDING — IB	
FP-MN02	FIRE PROTECTION	—	—	1000	215	—	—	100	1,760	460	3	60	•	—	50	104	•	—	1.0	40	85	•	—	—	—	—	—			—	1	•	—	•	—	—	—			HALAWA PORTAL BUILDING—IB	
FP-MN03 JOCKEY PUMP	FIRE PROTECTION	—	—	35	215	—	—	3	1,760	460	3	60	•	—	50	104	•	—	1.0	40	85	—	•	—	—	—	—			—	5	—	—	—	—	—	—			HALAWA PORTAL BUILDING—IB	
FP-MQ01	FIRE PROTECTION	—	—	1000	466	—	—	200	1,760	460	3	60	•	—	50	104	•	—	1.0	40	85	•	—	—	—	—	—			—	1	•	—	•	—	—	—			HAIKU PORTAL BUILDING—OB	
FP-MQ02	FIRE PROTECTION	—	—	1000	466	—	—	200	1,760	460	3	60	•	—	50	104	•	—	1.0	40	85	•	—	—	—	—	—			—	1	•	—	•	—	—	—			HAIKU PORTAL BUILDING—OB	
MP-1	MAKE-UP WATER (WELL PUMP)	—	—	100	1050	—	—	65	1,760	460	3	60	—	•	50	104	•	—	1.0	40	85	•	—	—	—	—	—			—	—	—	•	—	•	—	—				HALAWA APPROACH
MP-2A MP-2B	DOMESTIC WATER BOOSTER PUMP	—	—	40	107	—	—	1½	3,500	460	3	60	•	—	50	104	•	—	1.0	40	85	—	•	—	—	—	—			•	—	•	—	—	•	—	—				HALAWA PORTAL BUILDING—IB
MP-3	FUEL OIL TRANSFER PUMP	—	—	—	—	—	—	1/3	1,760	115	1	60	•	—	50	104	•	—	1.0	40	85	—	•	—	—	—	—			—	—	—	•	—	•	—	•				CONTROL BUILDING
MP-4	DRAINAGE TRANSFER PUMP	—	—	400	42	—	—	7½	1,760	460	3	60	•	—	50	104	•	—	1.0	40	85	—	•	—	—	—	—			—	—	—	•	—	—	—	—				HAIKU APPROACH
MP-5	MAKE-UP WATER (WELL PUMP)	—	—	100	430	—	—	25	1,760	460	3	60	—	•	50	104	•	—	1.0	40	85	•	—	—	—	—	—			—	—	—	•	—	•	—	—				HAIKU APPROACH
MP-6A MP-6B	DOMESTIC WATER BOOSTER PUMP	—	—	10	107	—	—	1½	3,500	460	3	60	•	—	50	104	•	—	1.0	40	85	—	•	—	—	—	—			•	—	•	—	—	•	—	—				HAIKU PORTAL BUILDING—OB
MP-7	DRAINAGE TRANSFER PUMP	—	—	400	42	—	—	7½	1,760	460	3	60	•	—	50	104	•	—	1.0	40	85	—	•	—	—	—	—			—	—	—	•	—	—	—	—				HALAWA APPROACH

FOR DETAIL AS-BUILT INFORMATION
REFER TO CONSTRUCTION SUBMITTALS

SURVEY PLOTTED BY	DATE
DRAWN BY	
DESIGNED BY	
CHECKED BY	
ORIGINAL PLAN	
NOTE BOOK	
NO.	

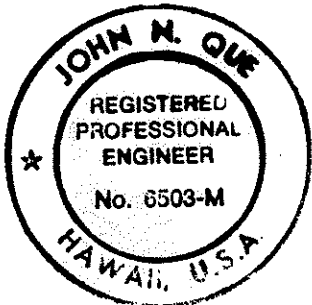


THIS WORK WAS PREPARED BY ME
OR UNDER MY SUPERVISION


John M. Oke

DATE	REVISION
STATE OF HAWAII DEPARTMENT OF TRANSPORTATION HIGHWAYS DIVISION	
MECHANICAL EQUIPMENT SCHEDULES I STANDARDS INTERSTATE ROUTE H-3 F.A.I. PROJ. NO. I-H3-1(66)	
SCALE: NONE	DATE: APR 1992
SHEET NO. M7	OF 28 SHEETS

FED. ROAD DIST. NO.	STATE	FED. AID PROJ. NO.	FISCAL YEAR	SHEET NO.	TOTAL SHEETS
HAWAII	HAW.	I-H3-1(66)	1992	19	440

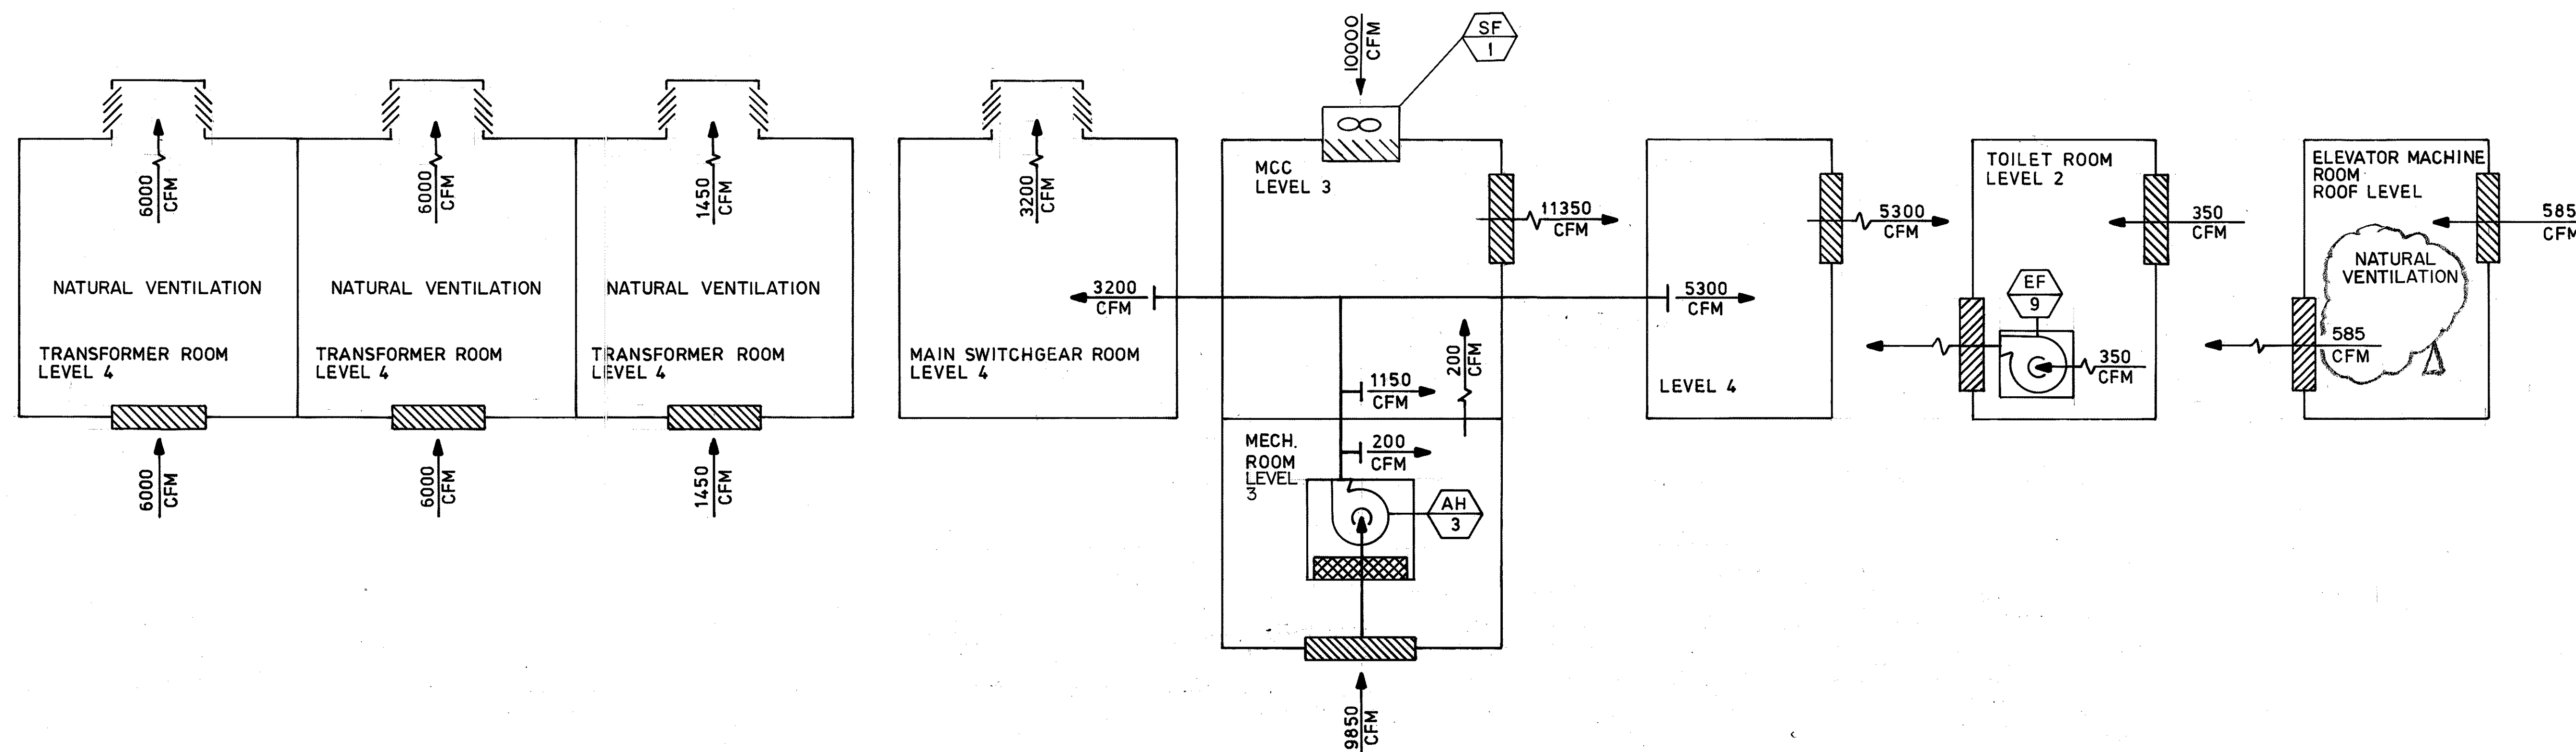


HALAWA PORTAL BUILDING OB

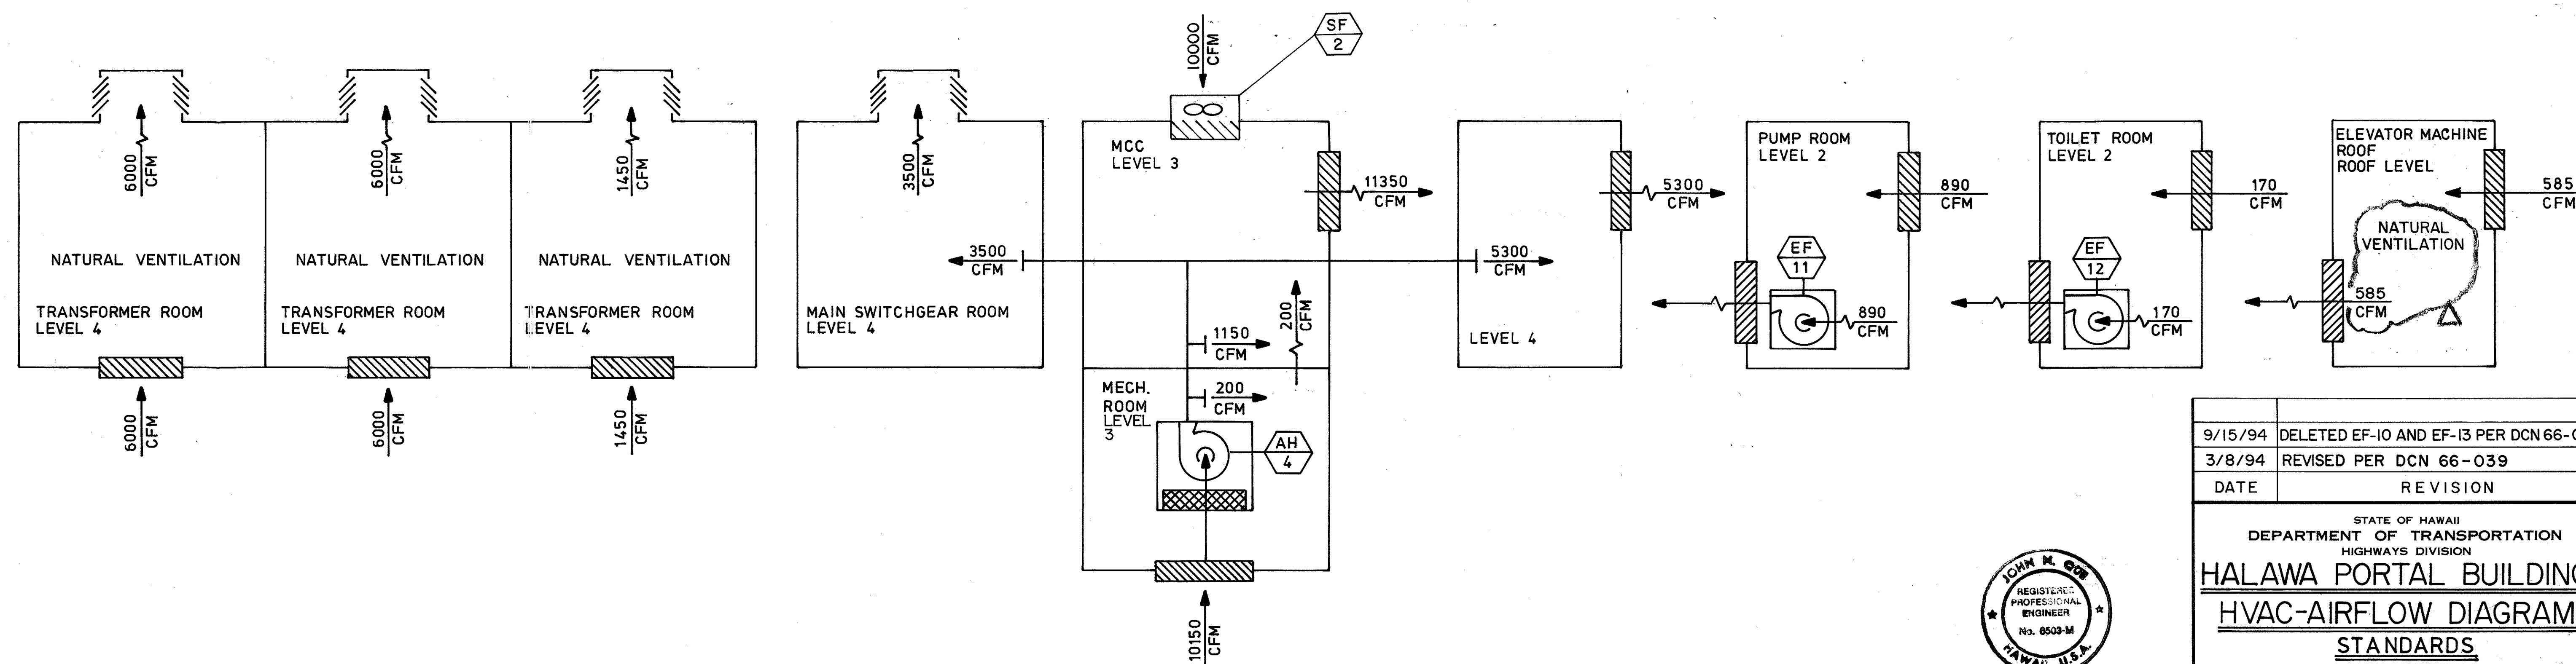

HALAWA PORTAL BUILDING IB

ORIGINAL PLAN	DATE
NO. 1	8/12/89
DESIGNED BY	8/18/89
QUANTITIES BY	8/19/90
CHECKED BY	


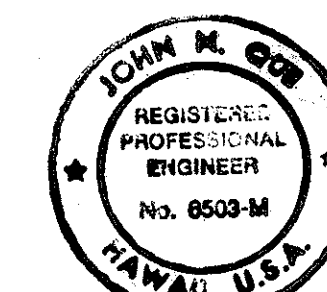


THIS WORK WAS PREPARED BY ME
OR UNDER MY SUPERVISION

John M. C.


9/15/94	DELETED EF-10 AND EF-13 PER DCN 66-052
3/8/94	REVISED PER DCN 66-039
DATE	REVISION
STATE OF HAWAII DEPARTMENT OF TRANSPORTATION HIGHWAYS DIVISION HALAWA PORTAL BUILDINGS HVAC-AIRFLOW DIAGRAMS STANDARDS INTERSTATE ROUTE H-3 F.A.I. PROJ. NO. I-H3-1(66) SCALE: NONE DATE: APR 1992 SHEET NO. M9 OF 28 SHEETS	

FED. ROAD DIST. NO.	STATE	FED. AID PROJ. NO.	FISCAL YEAR	SHEET NO.	TOTAL SHEETS
HAWAII	HAW.	I-H3-1(66)	1992	20	440

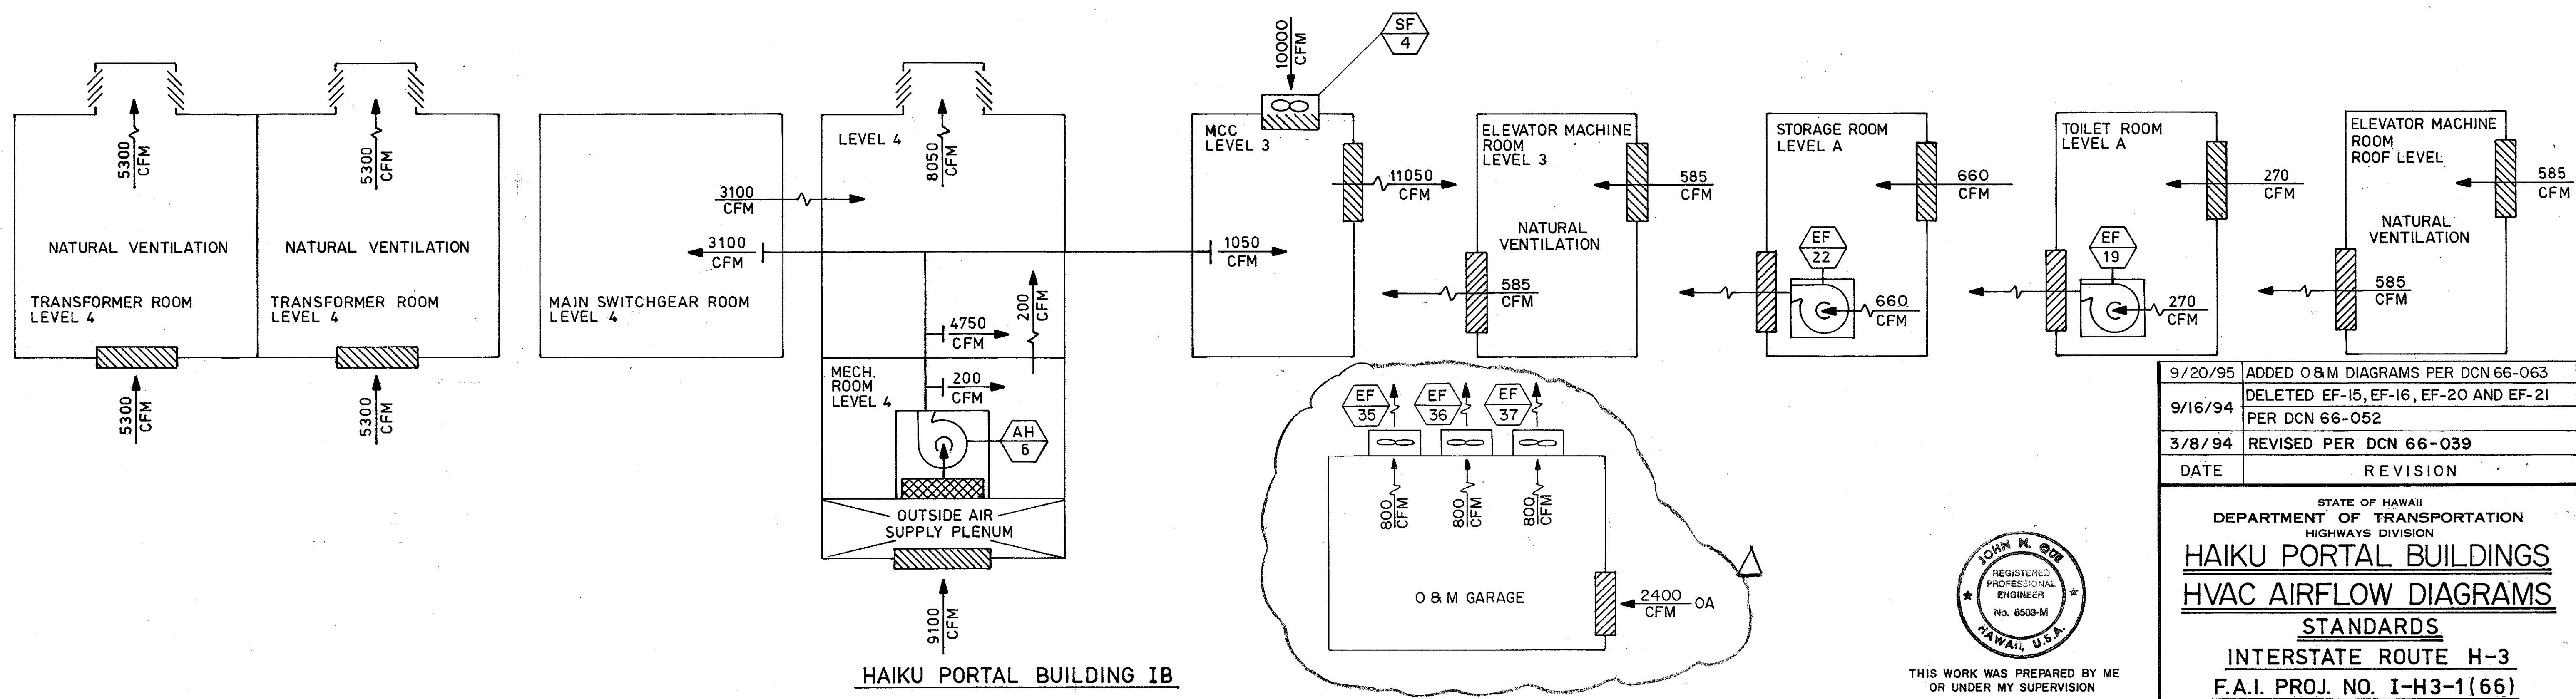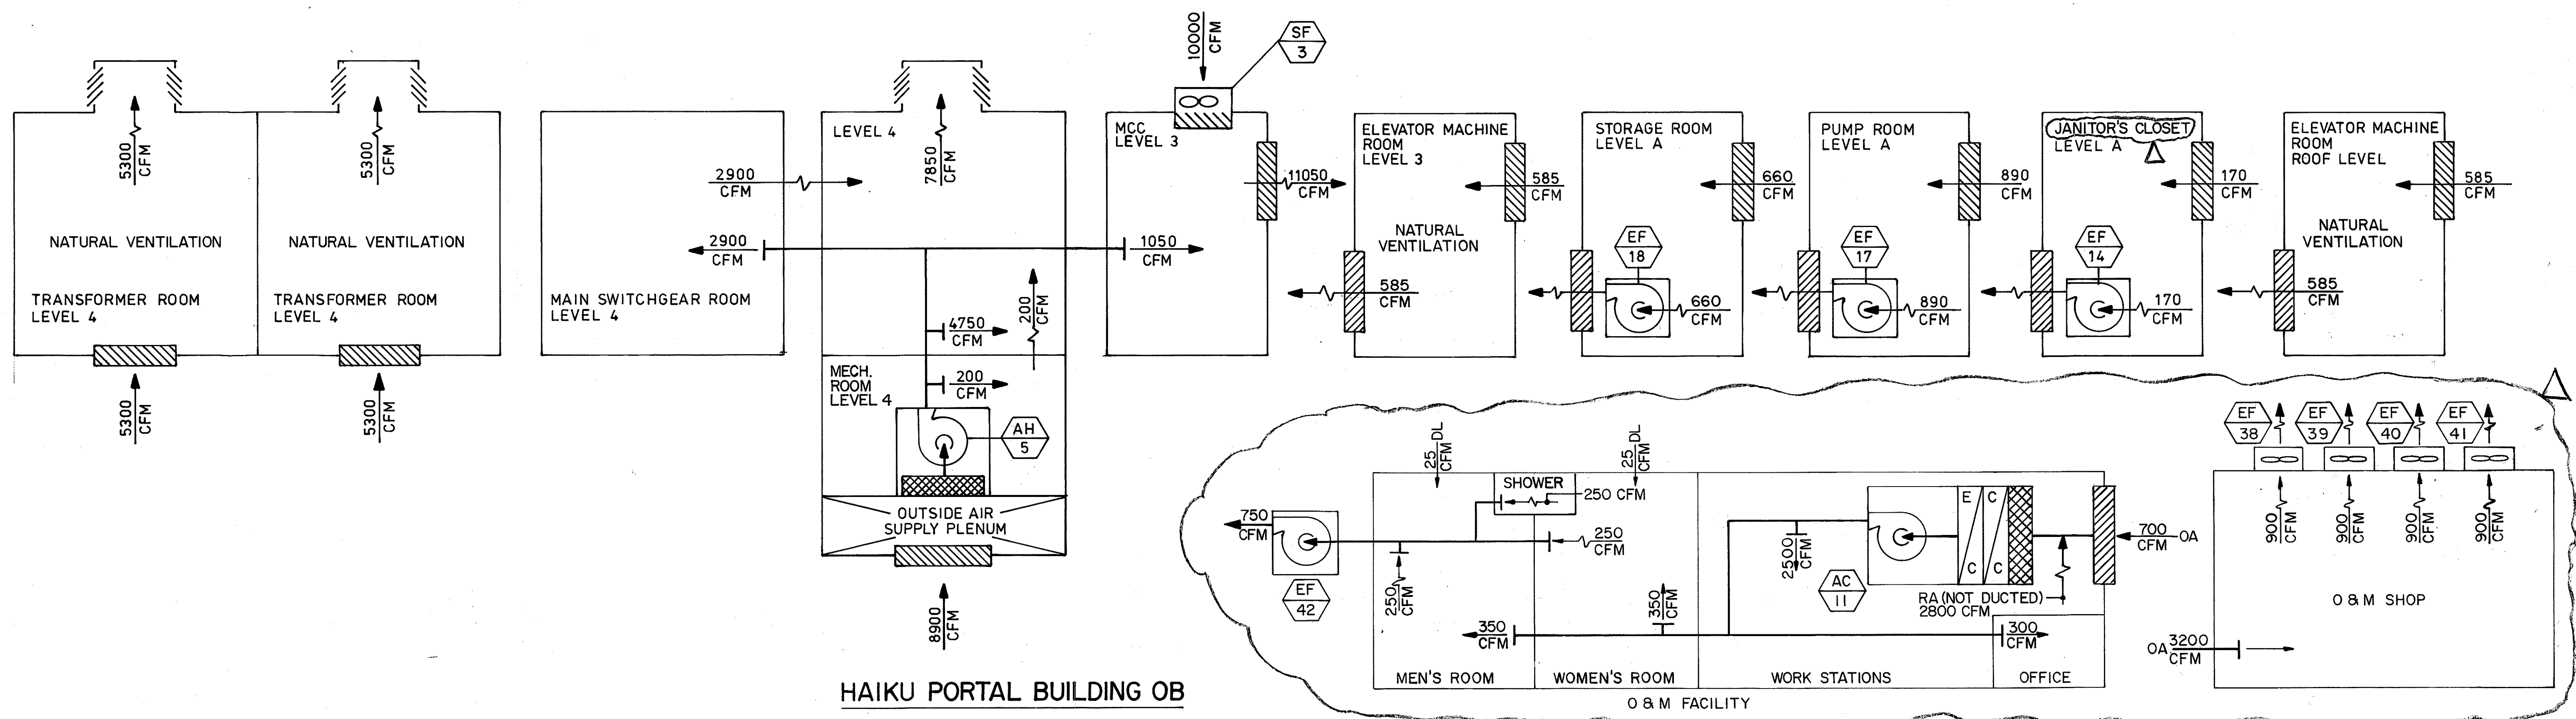

ORIGINAL PLAN	DATE	9/13/89
SURVEY PLOTTED BY	D. E. DRYDEN	
DESIGNED BY	A. H. PORTIER	4/07/89
QUANTITIES BY	J. N. QUE	5/15/90
CHECKED BY		

9/20/95	ADDED O & M DIAGRAMS PER DCN 66-063
9/16/94	DELETED EF-15, EF-16, EF-20 AND EF-21 PER DCN 66-052
3/8/94	REVISED PER DCN 66-039
DATE	REVISION

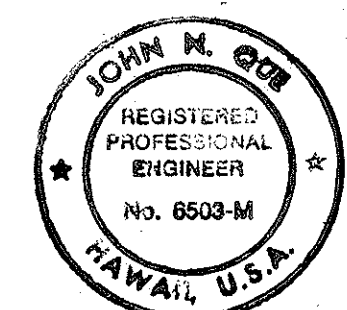

THIS WORK WAS PREPARED BY ME OR UNDER MY SUPERVISION

John H. Porter


STATE OF HAWAII
DEPARTMENT OF TRANSPORTATION
HIGHWAYS DIVISION

**HAIKU PORTAL BUILDINGS
HVAC AIRFLOW DIAGRAMS
STANDARDS**

INTERSTATE ROUTE H-3
F.A.I. PROJ. NO. I-H3-1(66)


SCALE: NONE DATE: APR 1992
SHEET NO. M10 OF 28 SHEETS

FED. ROAD DIST. NO.	STATE	FED. AID PROJ. NO.	FISCAL YEAR	SHEET NO.	TOTAL SHEETS
HAWAII	HAW.	I-H3-1(66)	1992	21	440

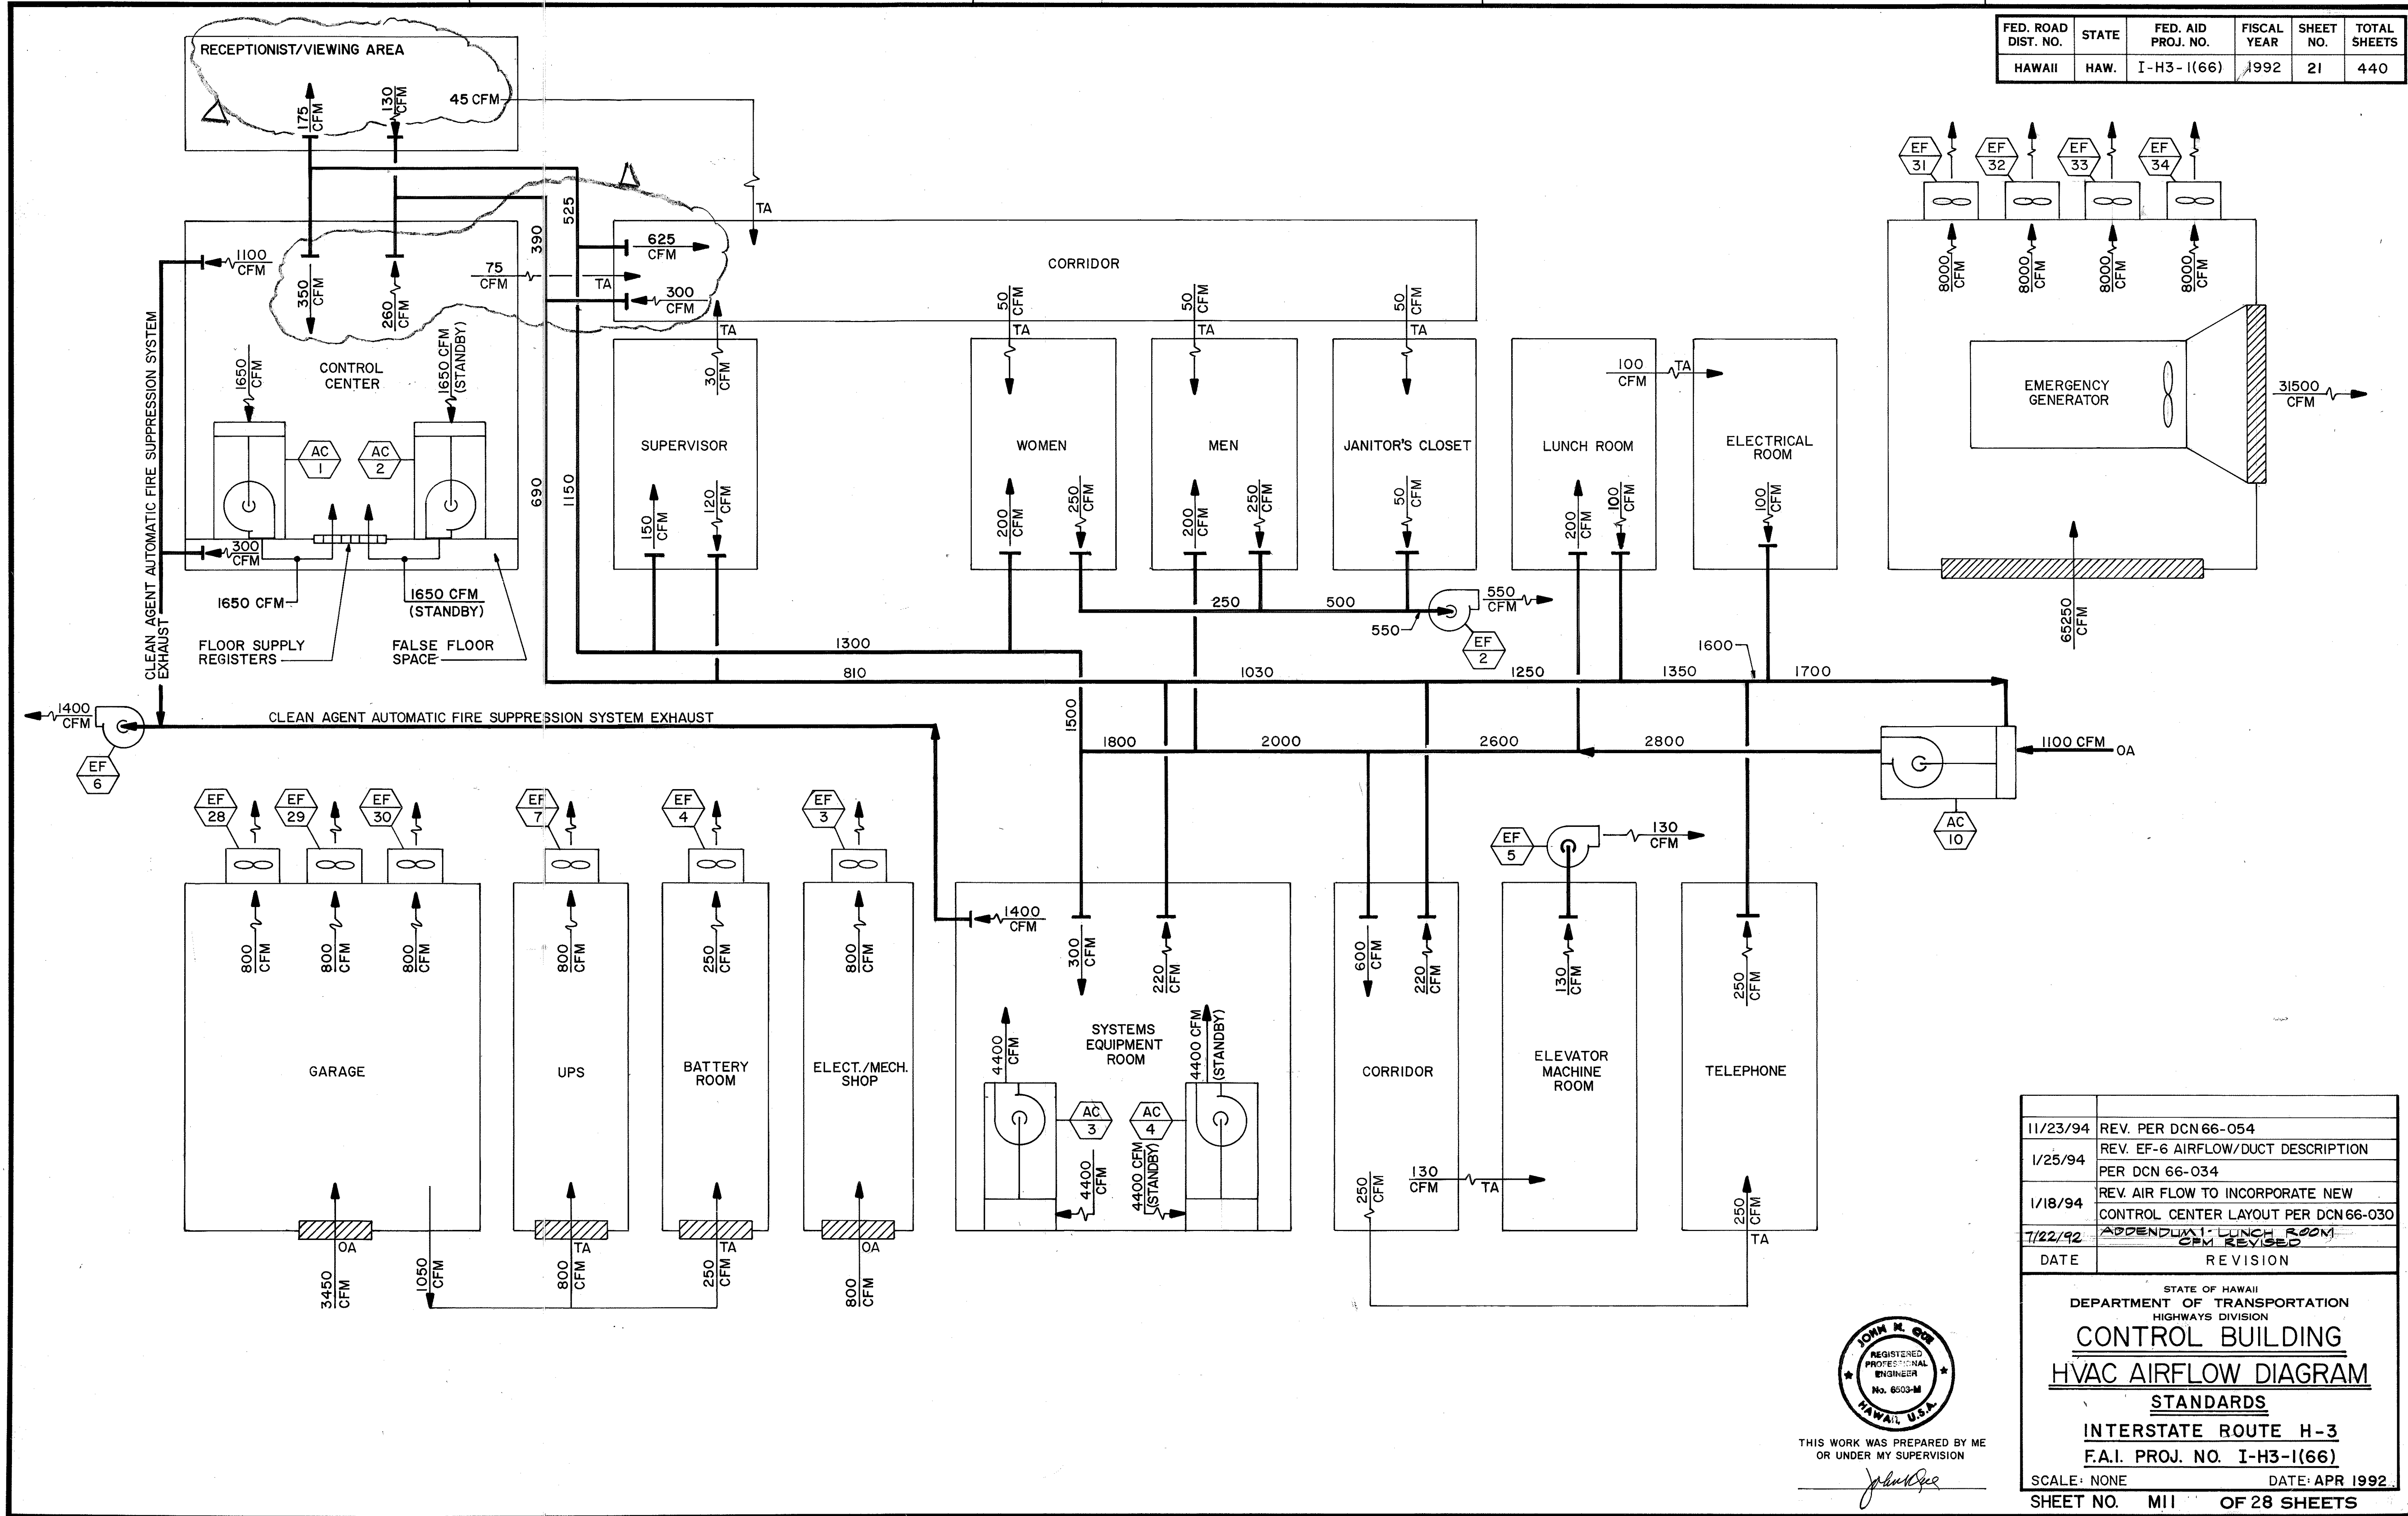

ORIGINAL PLAN	DATE
NO. 1	01/03/90
NO. 2	12/07/93
NO. 3	06/18/90


11/23/94	REV. PER DCN 66-054
1/25/94	REV. EF-6 AIRFLOW/DUCT DESCRIPTION PER DCN 66-034
1/18/94	REV. AIR FLOW TO INCORPORATE NEW CONTROL CENTER LAYOUT PER DCN 66-030
7/22/92	APPENDIX 1 LUNCH ROOM CFM REVISED
DATE	REVISION

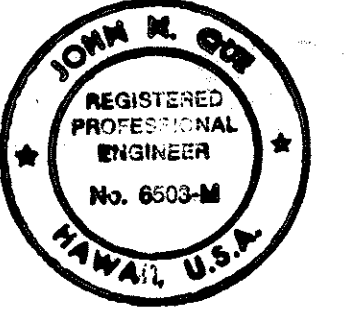

THIS WORK WAS PREPARED BY ME OR UNDER MY SUPERVISION

STATE OF HAWAII
DEPARTMENT OF TRANSPORTATION
HIGHWAYS DIVISION
CONTROL BUILDING
HVAC AIRFLOW DIAGRAM
STANDARDS
INTERSTATE ROUTE H-3
F.A.I. PROJ. NO. I-H3-1(66)
SCALE: NONE DATE: APR 1992
SHEET NO. MII OF 28 SHEETS


FED. ROAD DIST. NO.	STATE	FED. AID PROJ. NO.	FISCAL YEAR	SHEET NO.	TOTAL SHEETS
HAWAII	HAW.	I-H3-1(61)	1992	22	440

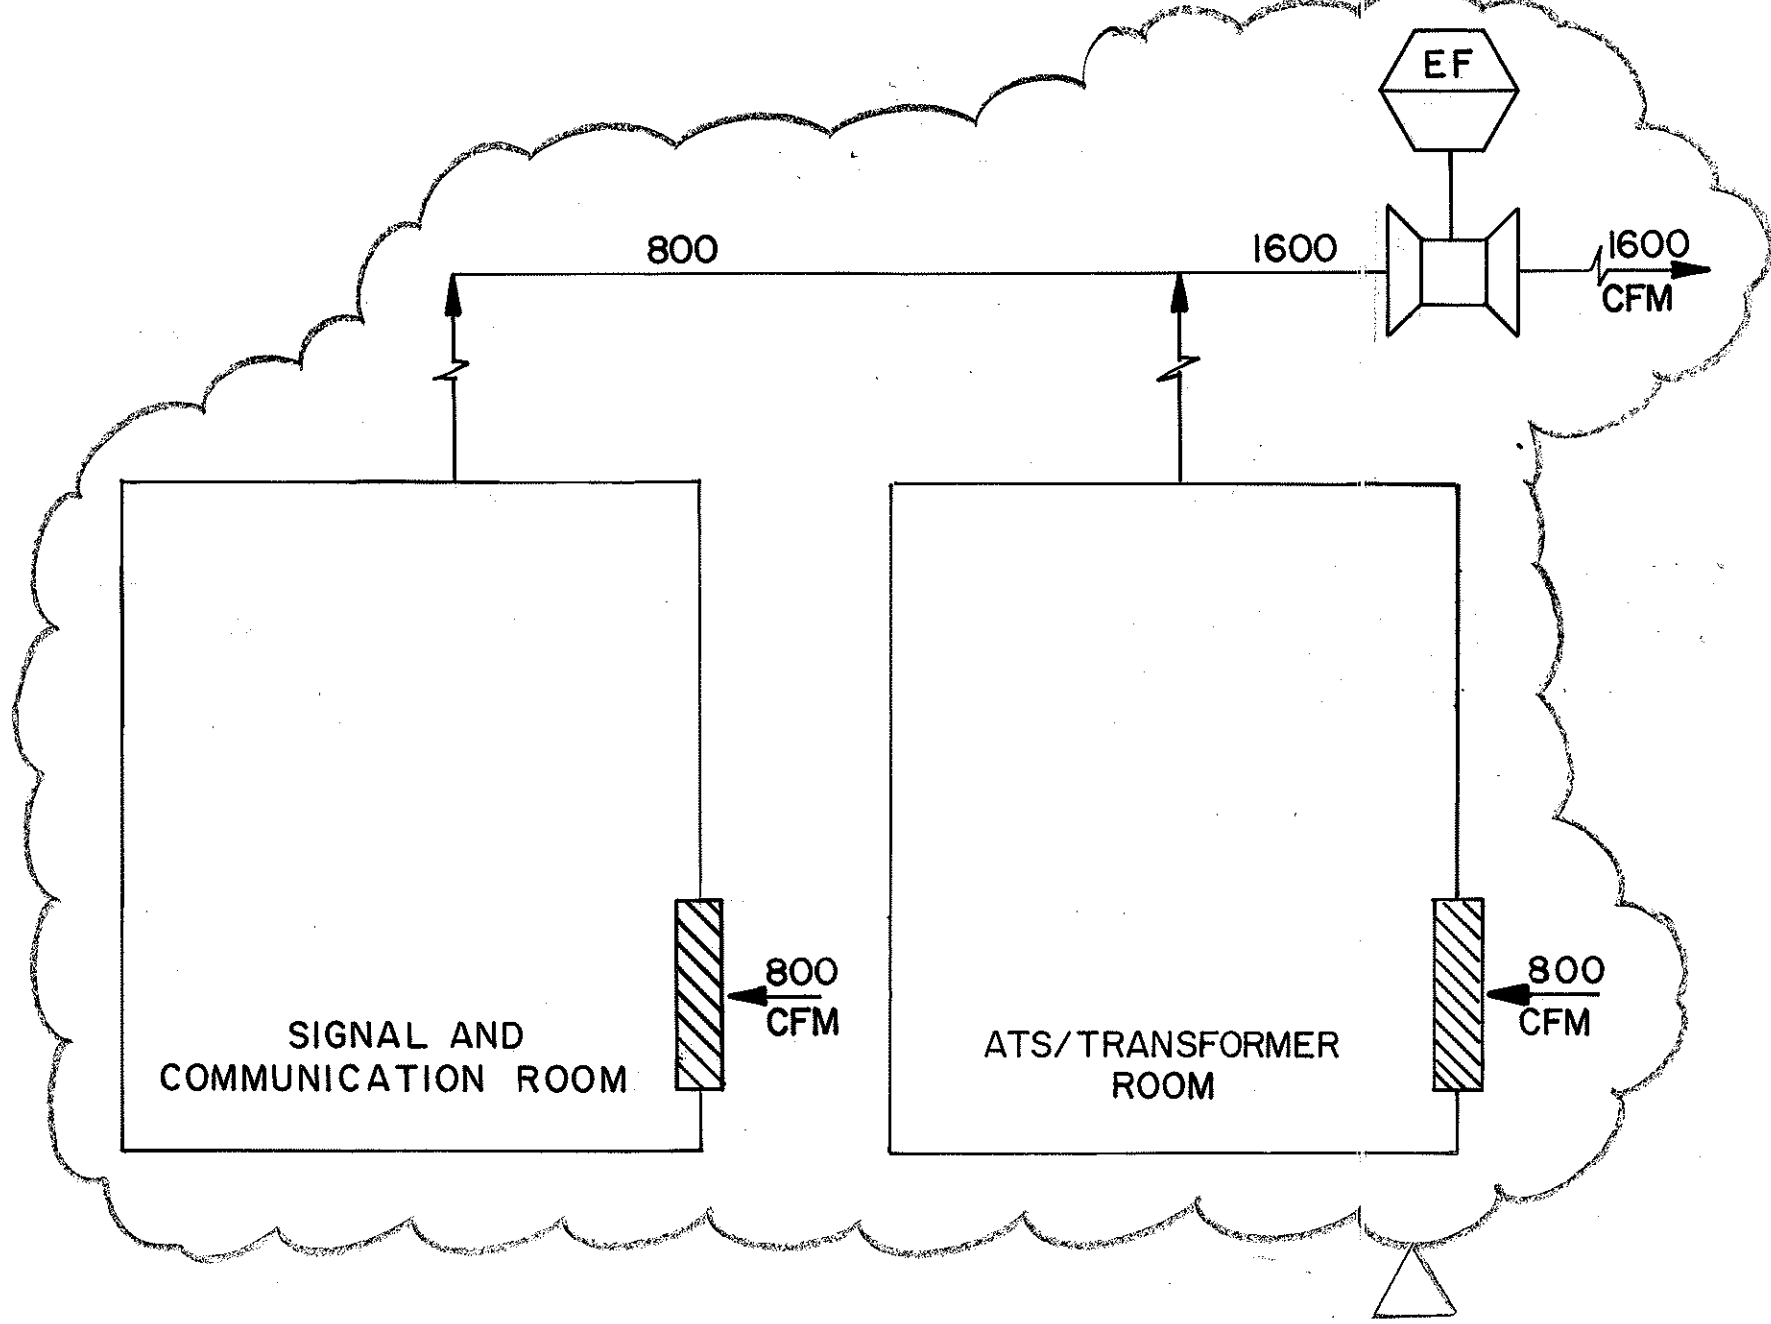

TYPICAL FOR CROSSPAGE NOS. 1, 3, 5, 7 & 9
(SEE SCHEDULE)

AIRFLOW DIAGRAM

CROSSPASSAGE HVAC & VENTILATION SCHEDULE		
CROSS-PASSAGE #	ROOM	FAN
NO. 1	SIGNAL AND COMMUNICATION RM AND ATS/TRANSFORMER	EF-23
NO. 3	SIGNAL AND COMMUNICATION RM AND ATS/TRANSFORMER	EF-24
NO. 5	SIGNAL AND COMMUNICATION RM AND ATS/TRANSFORMER	EF-25
NO. 7	SIGNAL AND COMMUNICATION RM AND ATS/TRANSFORMER	EF-26
NO. 9	SIGNAL AND COMMUNICATION RM AND ATS/TRANSFORMER	EF-27

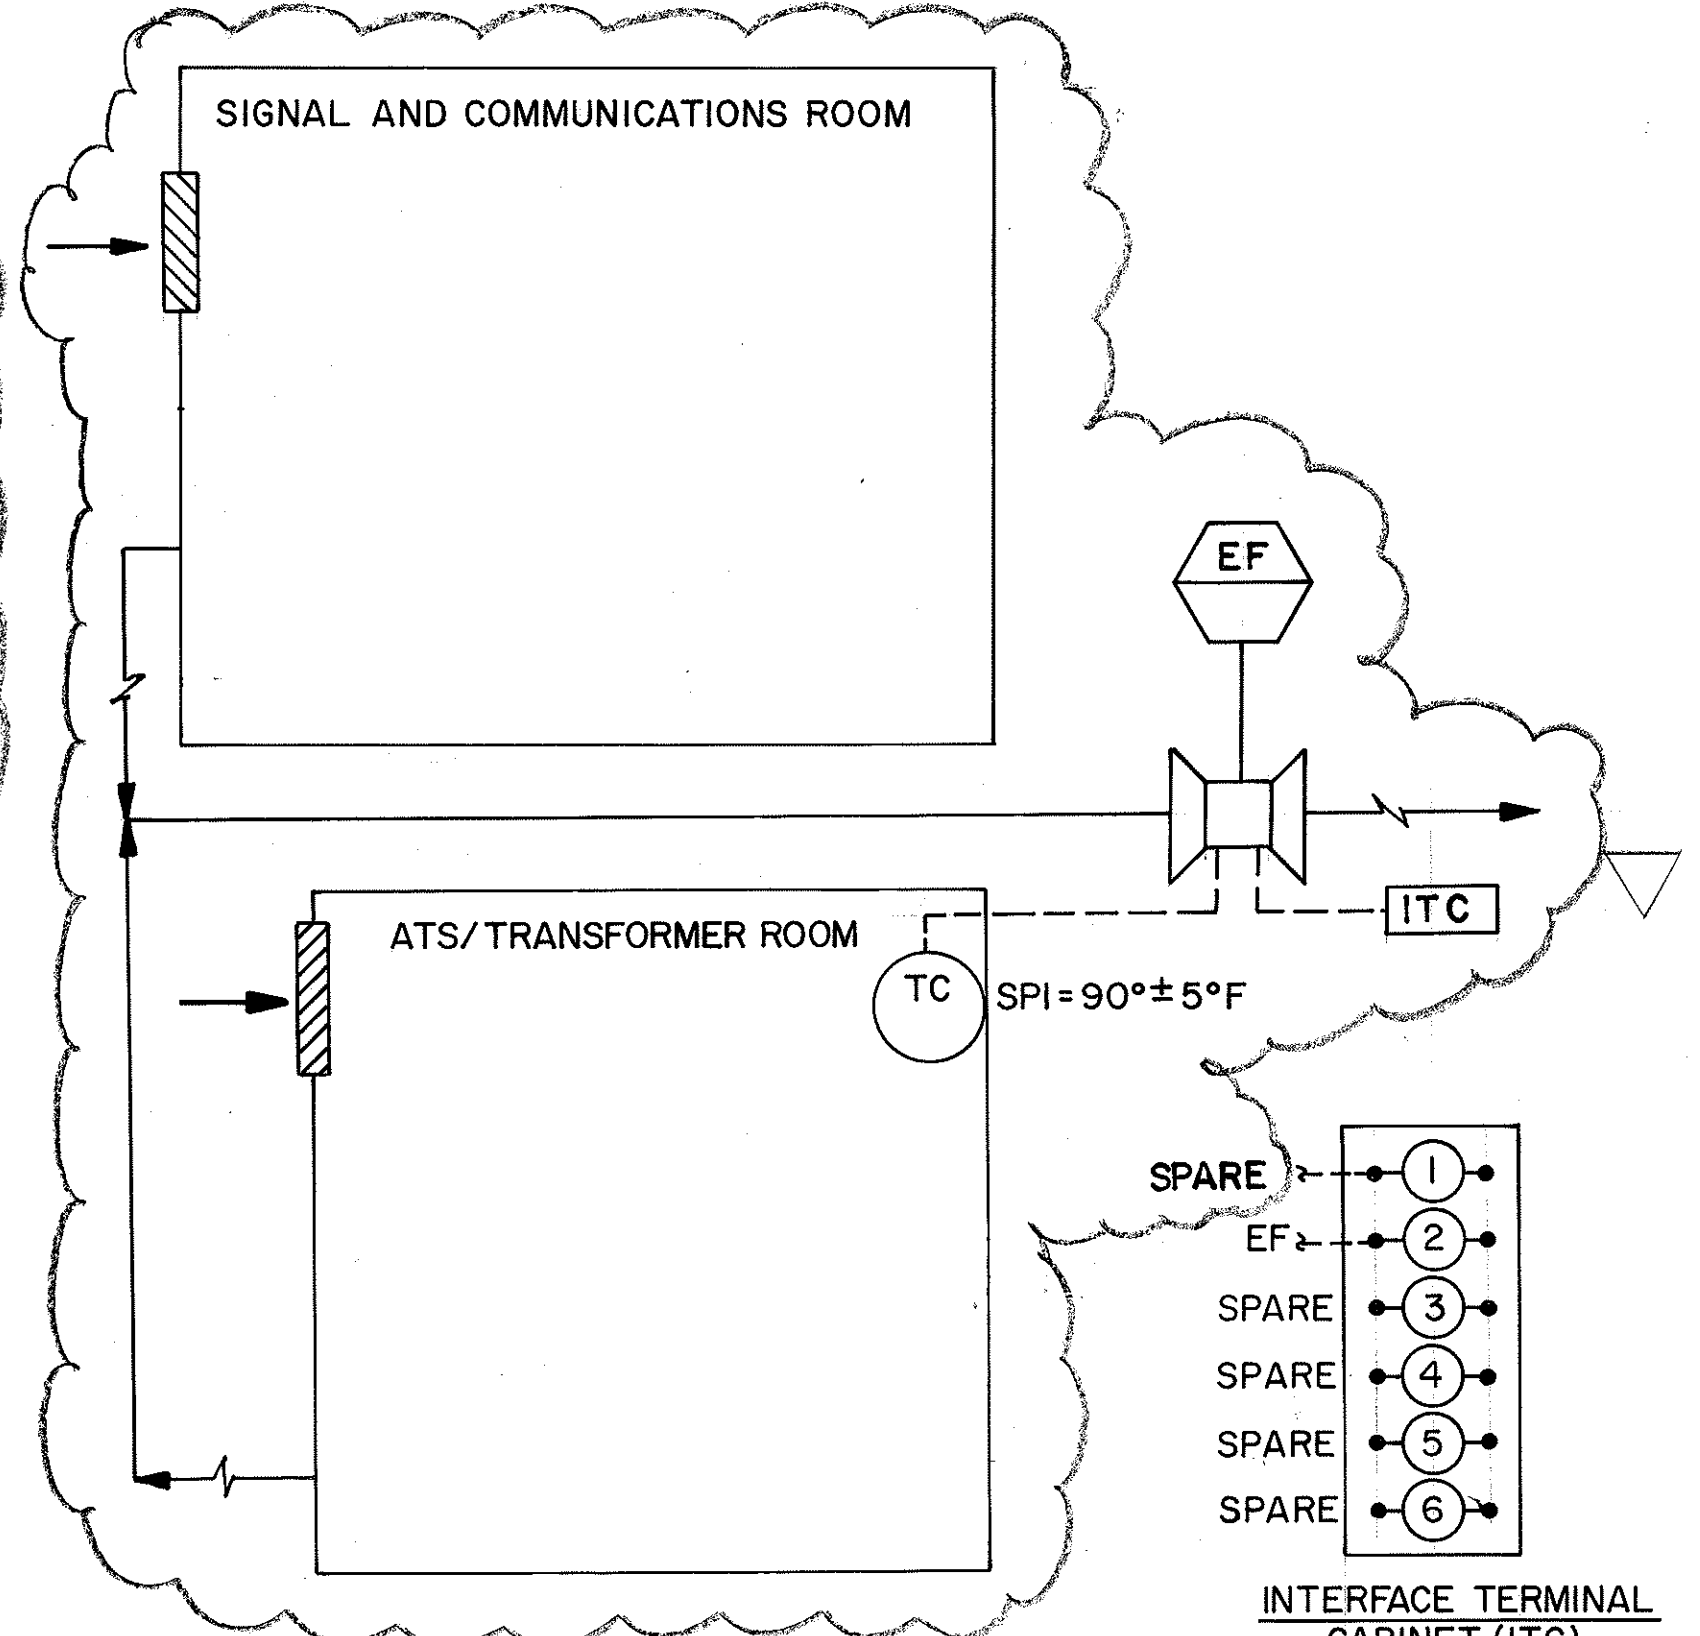


TYPICAL FOR CROSSPASSAGE NOS. 1, 3, 5, 7 & 9
(SEE SCHEDULE)

CONTROL DIAGRAM

ORIGINAL PLAN	DATE
NO. 1	11/15/89
NO. 2	01/12/89
NO. 3	06/15/90

SURVEY PLOTTED BY	DATE
B. F. BUNYI	11/15/89
DESIGNED BY	01/12/89
A. H. PORTER	06/15/90
CHECKED BY	
J. N. QUE	

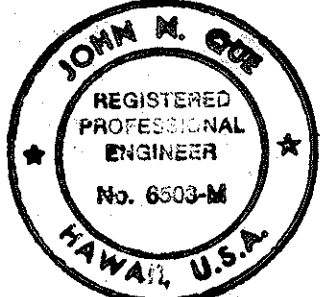

THIS WORK WAS PREPARED BY ME
OR UNDER MY SUPERVISION

John M. Que




3/3/94	DELETED AC UNITS AND REVISED EF PER DCN 66-037
DATE	REVISION
STATE OF HAWAII DEPARTMENT OF TRANSPORTATION HIGHWAYS DIVISION CROSSPASSAGES - HVAC AIRFLOW & CONTROL DIAGRAMS STANDARDS INTERSTATE ROUTE H-3 F.A.I. PROJ. NO. I-H3-1(66)	
SCALE: NONE	DATE: APR 1992
SHEET NO. M12 OF 28 SHEETS	

The diagram illustrates the terminal connections for the Interface Terminal Cabinet (ITC). It features a central vertical strip with six numbered terminals (1 through 6). The connections are as follows:

- Terminal 1:** Connected to **AH** (Air Handling Unit).
- Terminal 2:** Connected to **FLOW SWITCH**.
- Terminal 3:** Connected to **TC** (Temperature Control).
- Terminal 4:** Labeled **SPARE**.
- Terminal 5:** Labeled **SPARE**.
- Terminal 6:** Labeled **SPARE**.

At the top right, a line connects to **F.A.I. PROJ. I-H3-1(65)**.

INTERFACE TERMINAL
CABINET (ITC) DETAIL
(DUAL TERMINAL STRIP)

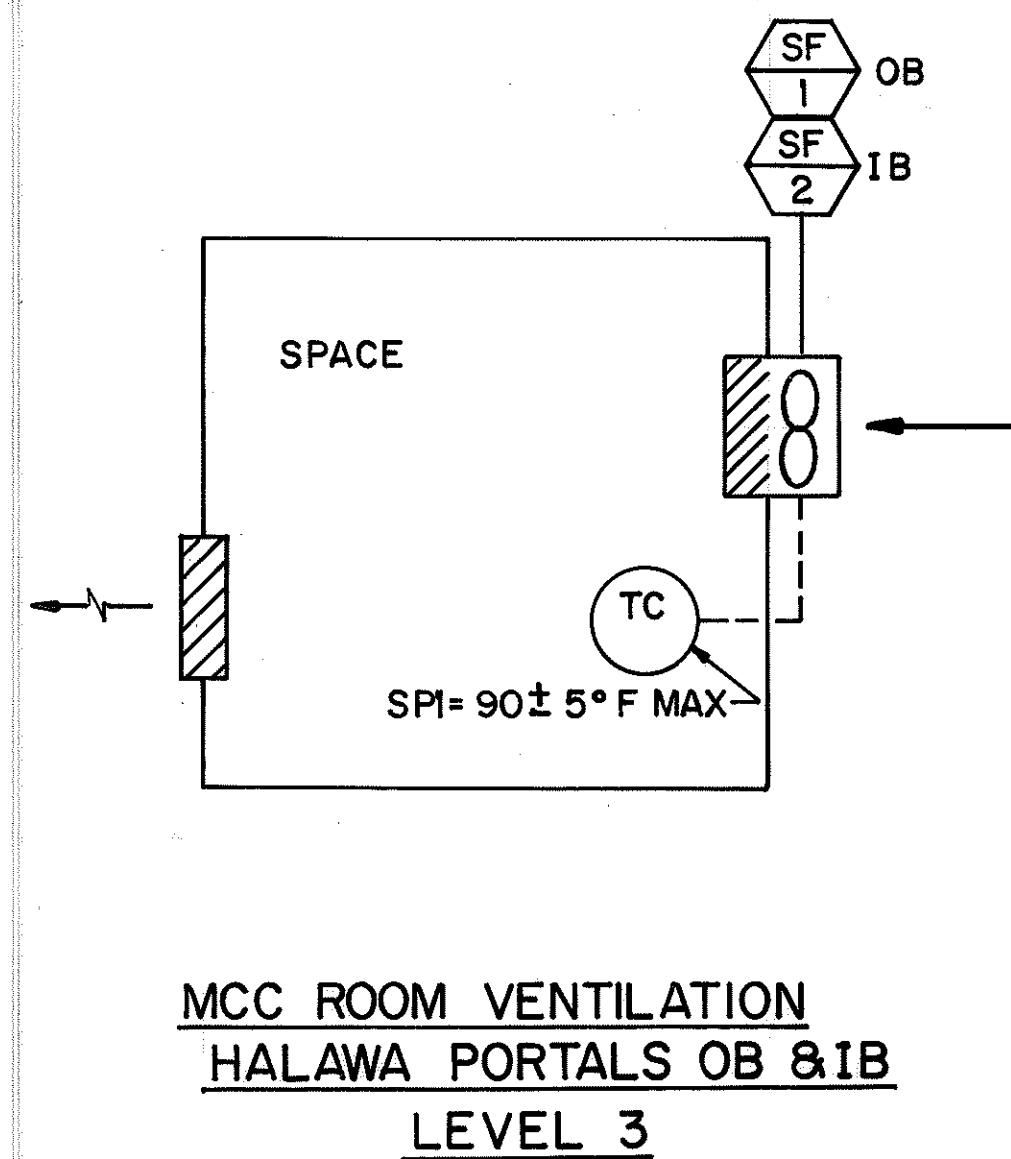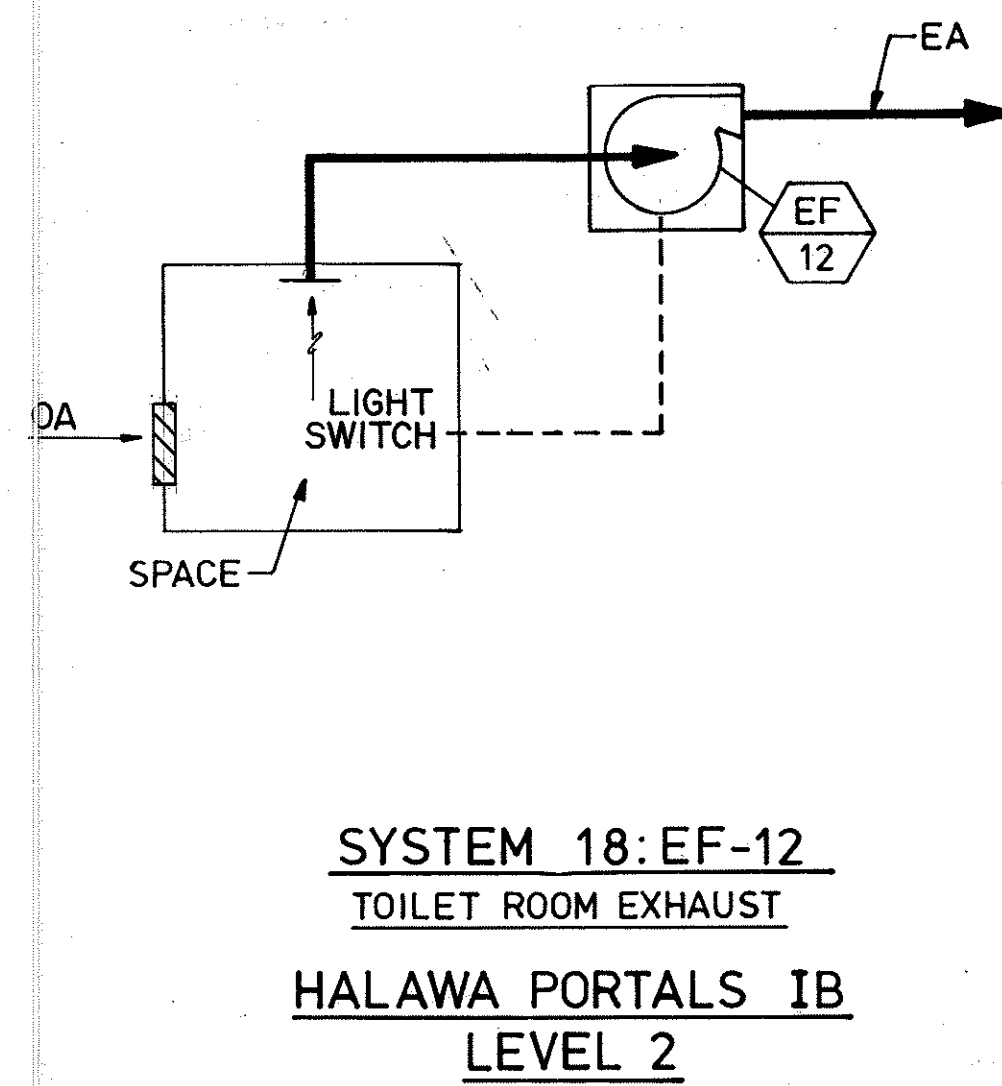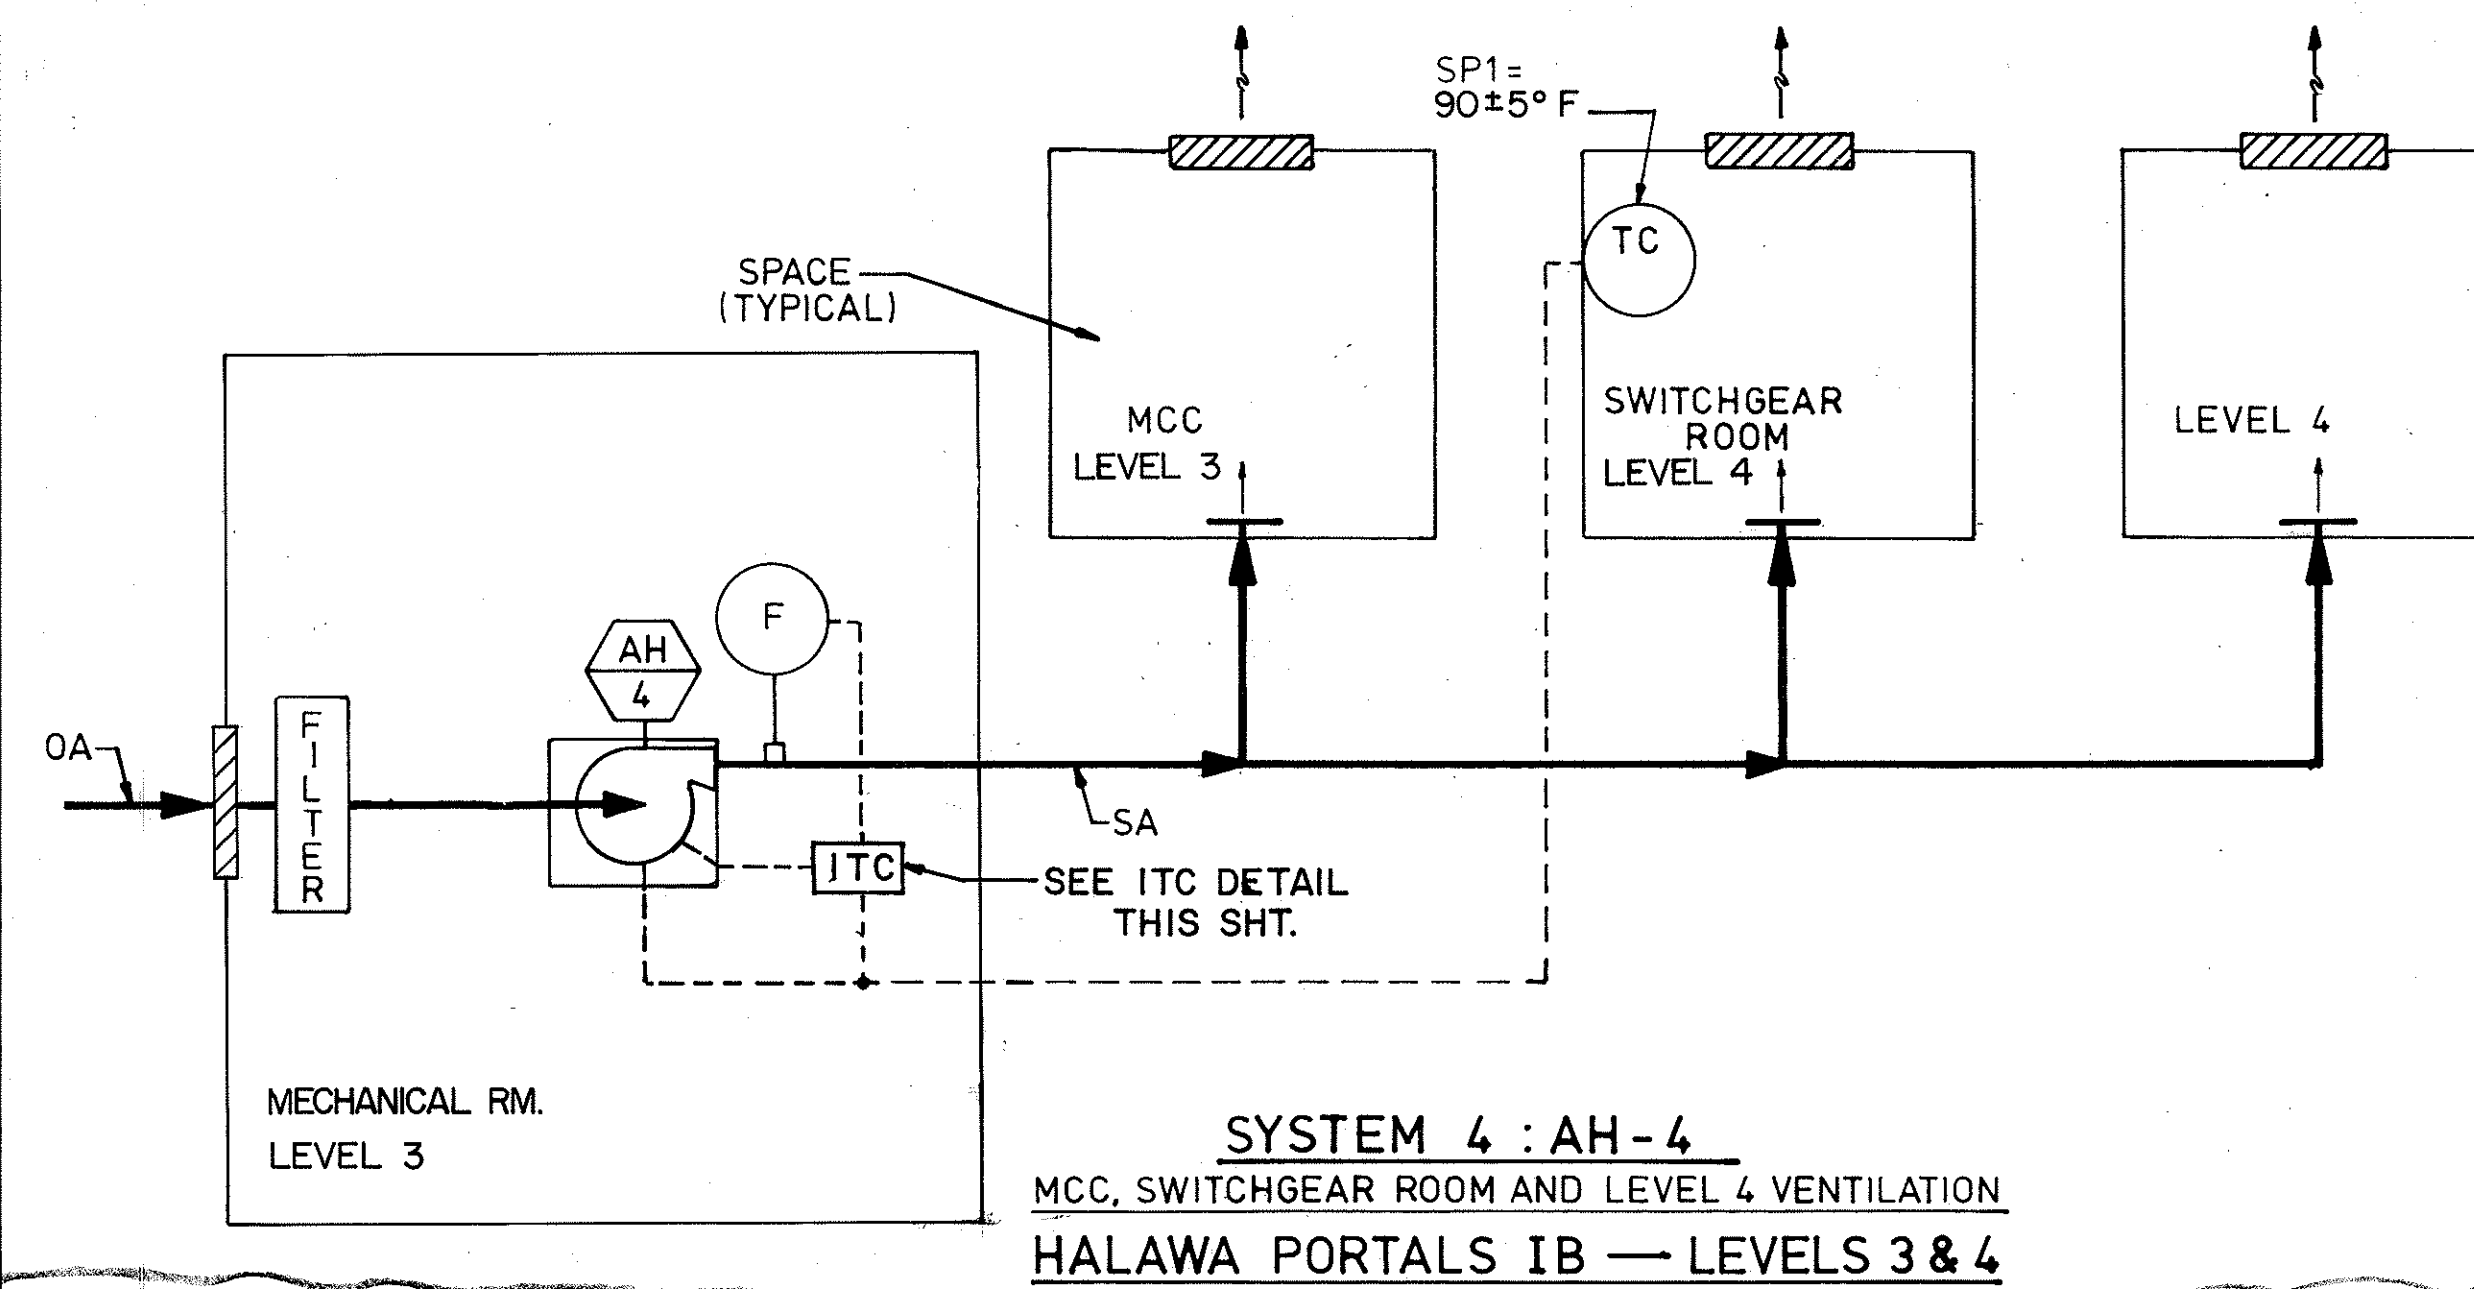

JOHN N. GUE
REGISTERED
PROFESSIONAL
ENGINEER
No. 8503-M
HAWAII, U.S.A.

THIS WORK WAS PREPARED
OR UNDER MY SUPERVISION

John N. Gue

9/15/94	DELETED SYSTEM I6:EF-10 AND SYSTEM I9: EF-13 PER DCN 66-052
3/9/ 94	REVISED PER DCN 66 - 039
DATE	REVISION

STATE OF HAWAII
 DEPARTMENT OF TRANSPORTATION
 HIGHWAYS DIVISION

HALAWA PORTAL BUILDINGS

HVAC CONTROL DIAGRAMS

STANDARDS

INTERSTATE ROUTE H-3

F.A.I. PROJ. NO. I-H3-1(66)













SCALE: NONE
DATE: APR 1992

SHEET NO. M13 OF 28 SHEETS

F.A.I. PROJ. NO.
I - H3-1(65)

AH	1	
FLOW SWITCH	2	
TC	3	
SPARE	4	
SPARE	5	
SPARE	6	

INTERFACE TERMINAL CABINET
(ITC) DETAIL
(DUAL TERMINAL STRIP)

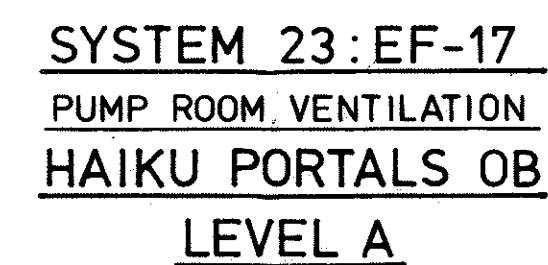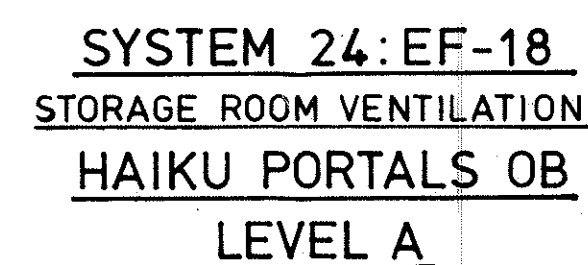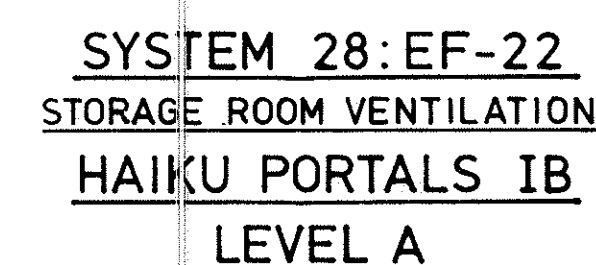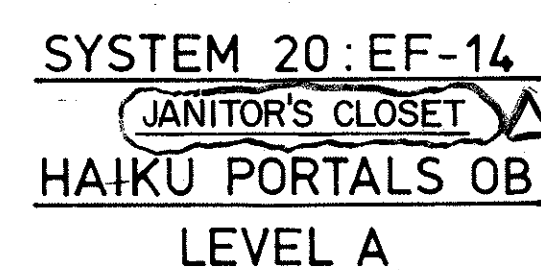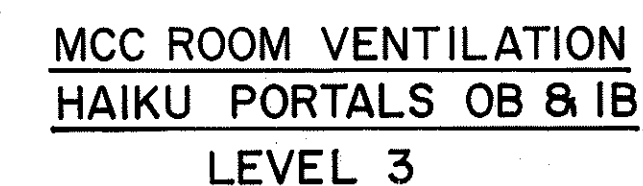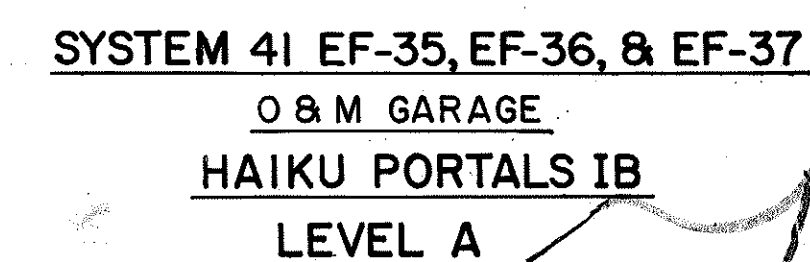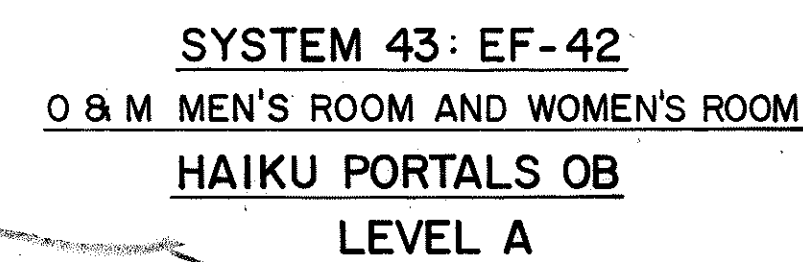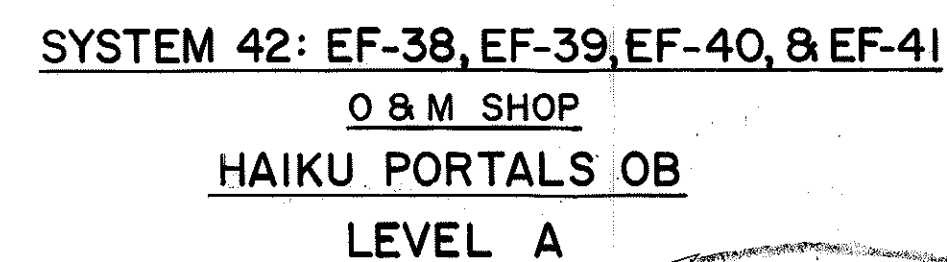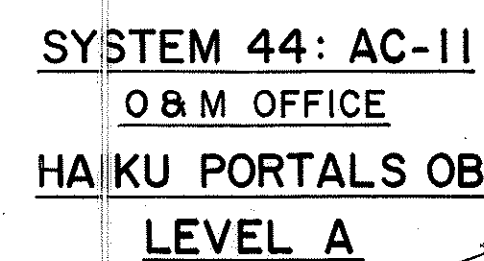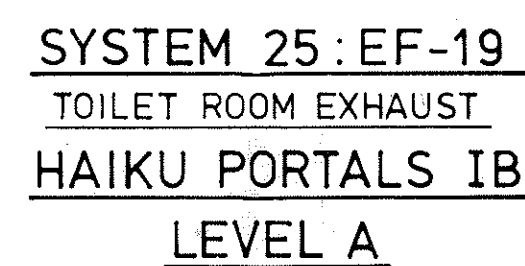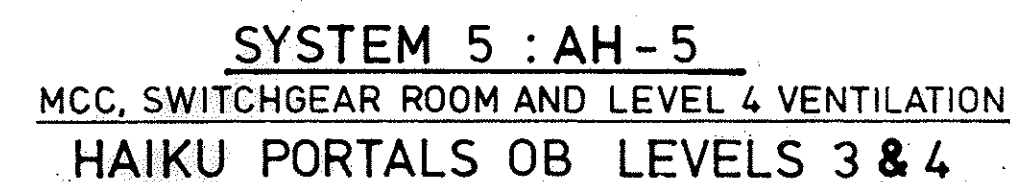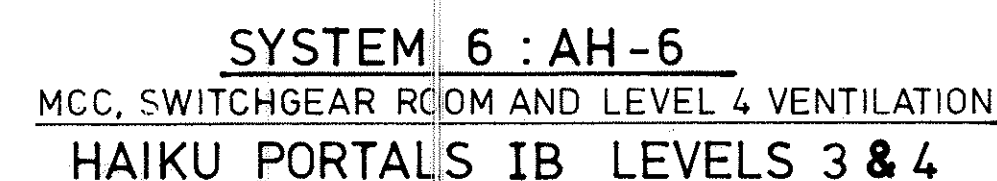


STATE OF HAWAII
DEPARTMENT OF TRANSPORTATION
HIGHWAYS DIVISION

HAIKU PORTAL BUILDINGS
HVAC CONTROL DIAGRAMS
STANDARDS
INTERSTATE ROUTE H-3
F.A.I. PROJ. NO. I-H3-1(66)


SCALE: NONE DATE: APR 1992

 SHEET NO. M14 OF 28 SHEETS




ORIGINAL PLAN	SURVEY PLOTTED BY _____	DATE _____
NOTE BOOK	DRAWN BY D. E. DRYDEN	8/30/89
	DESIGNED BY A. H. PORTER	8/15/89
	QUANTITIES BY _____	
No. _____	CHECKED BY J. N. QUE	6/18/90


FED. ROAD DIST. NO.	STATE	FED. AID PROJ. NO.	FISCAL YEAR	SHEET NO.	TOTAL SHEETS
HAWAII	HAW.	I-H3-1(66)	1992	25	440

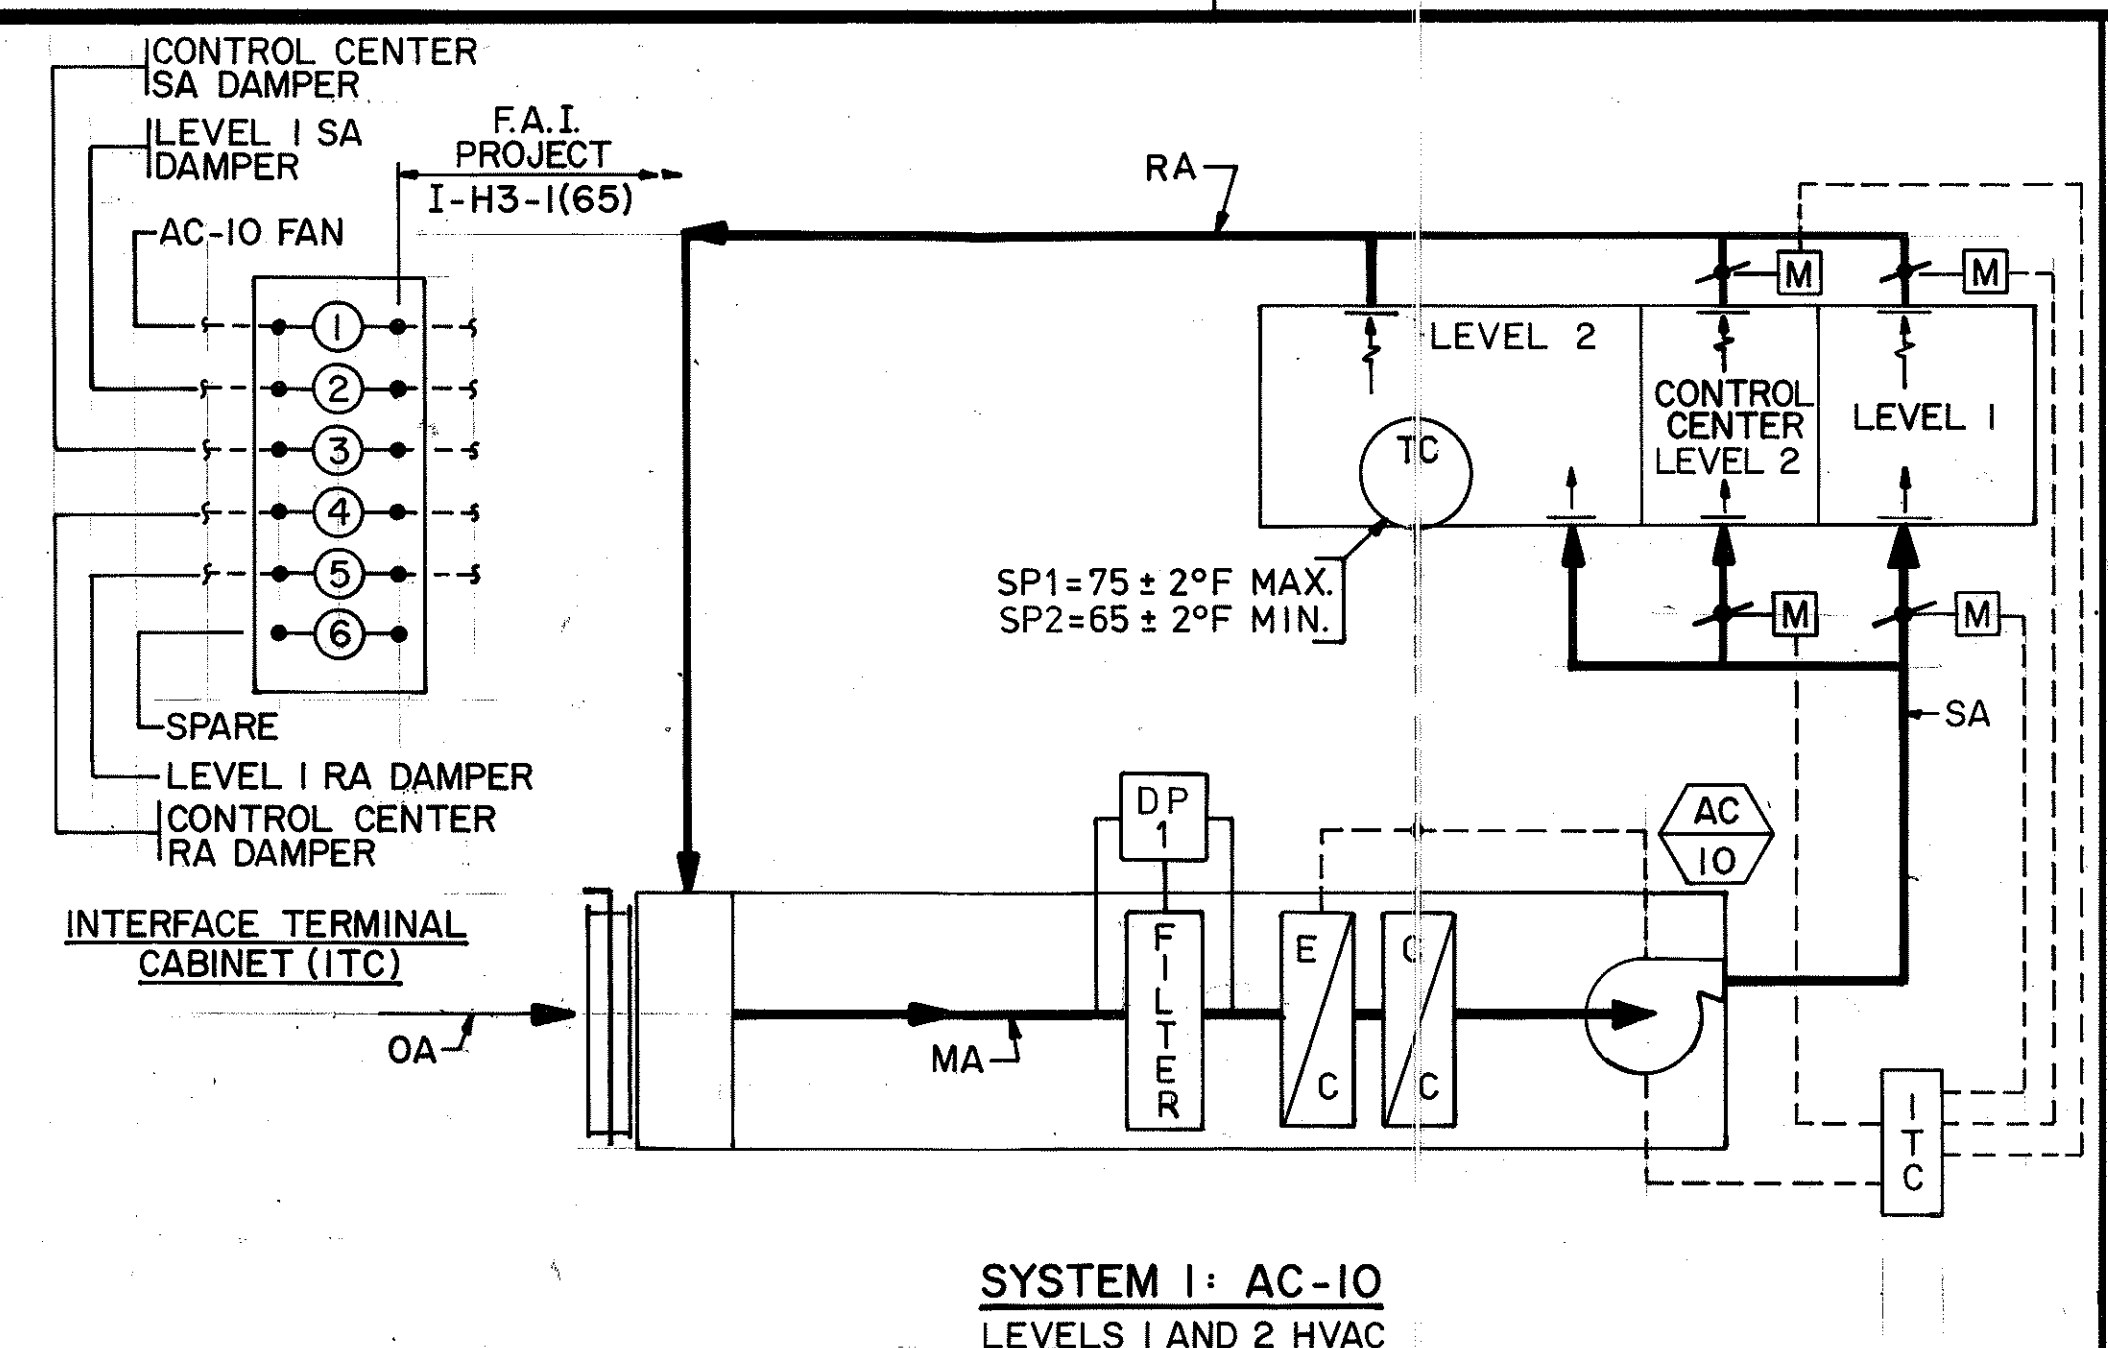


SYSTEM 1: AC-10
LEVELS 1 AND 2 HVAC

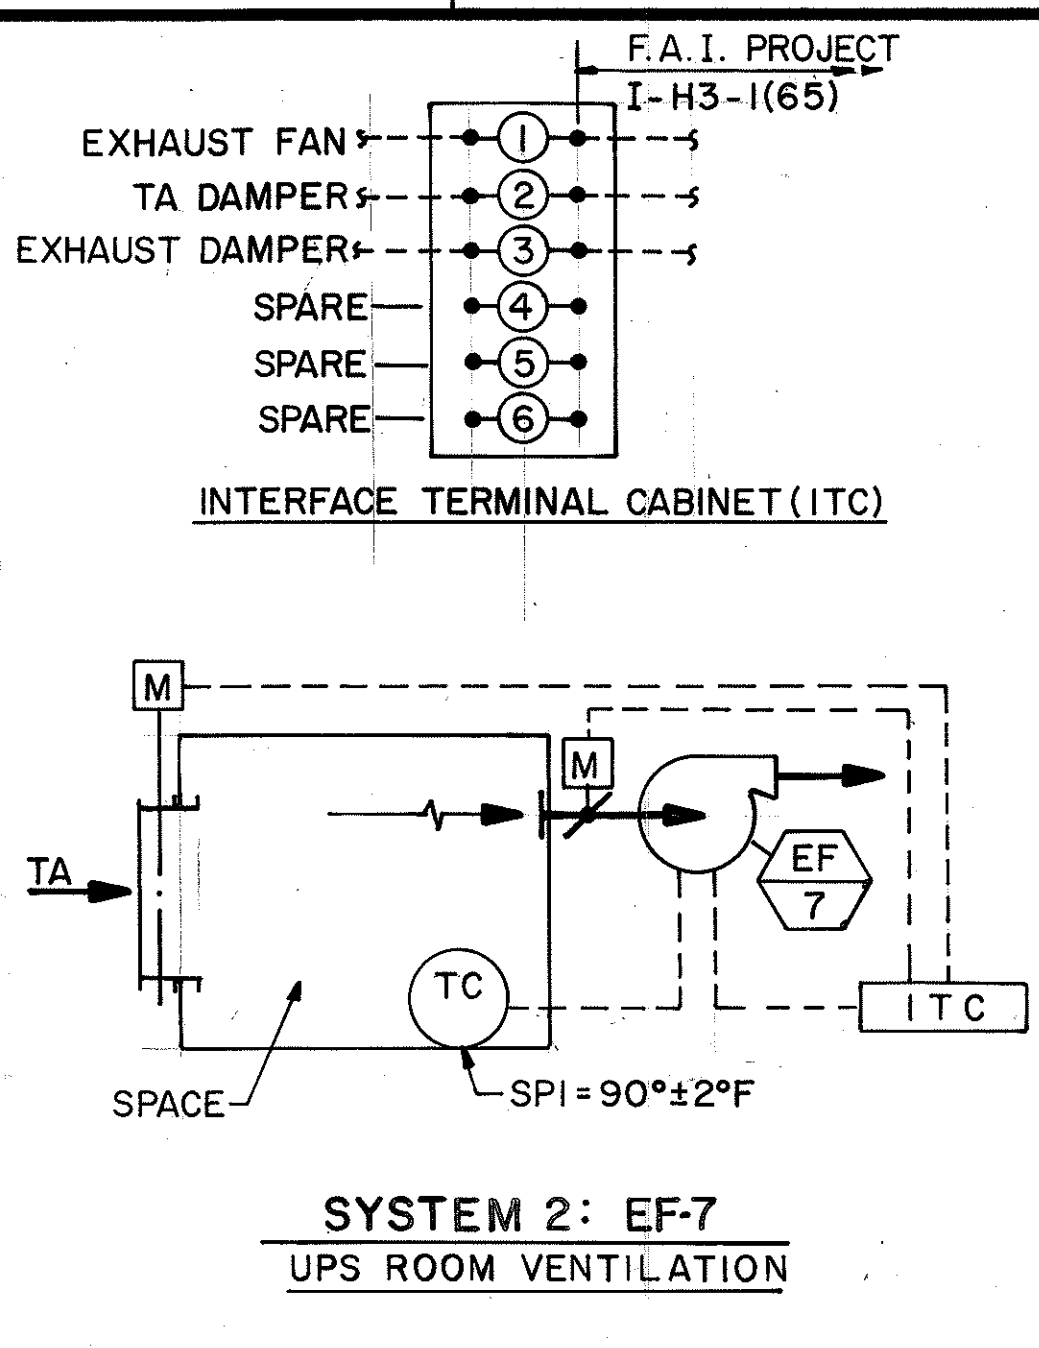


SYSTEM 2: EF-7
UPS ROOM VENTILATION

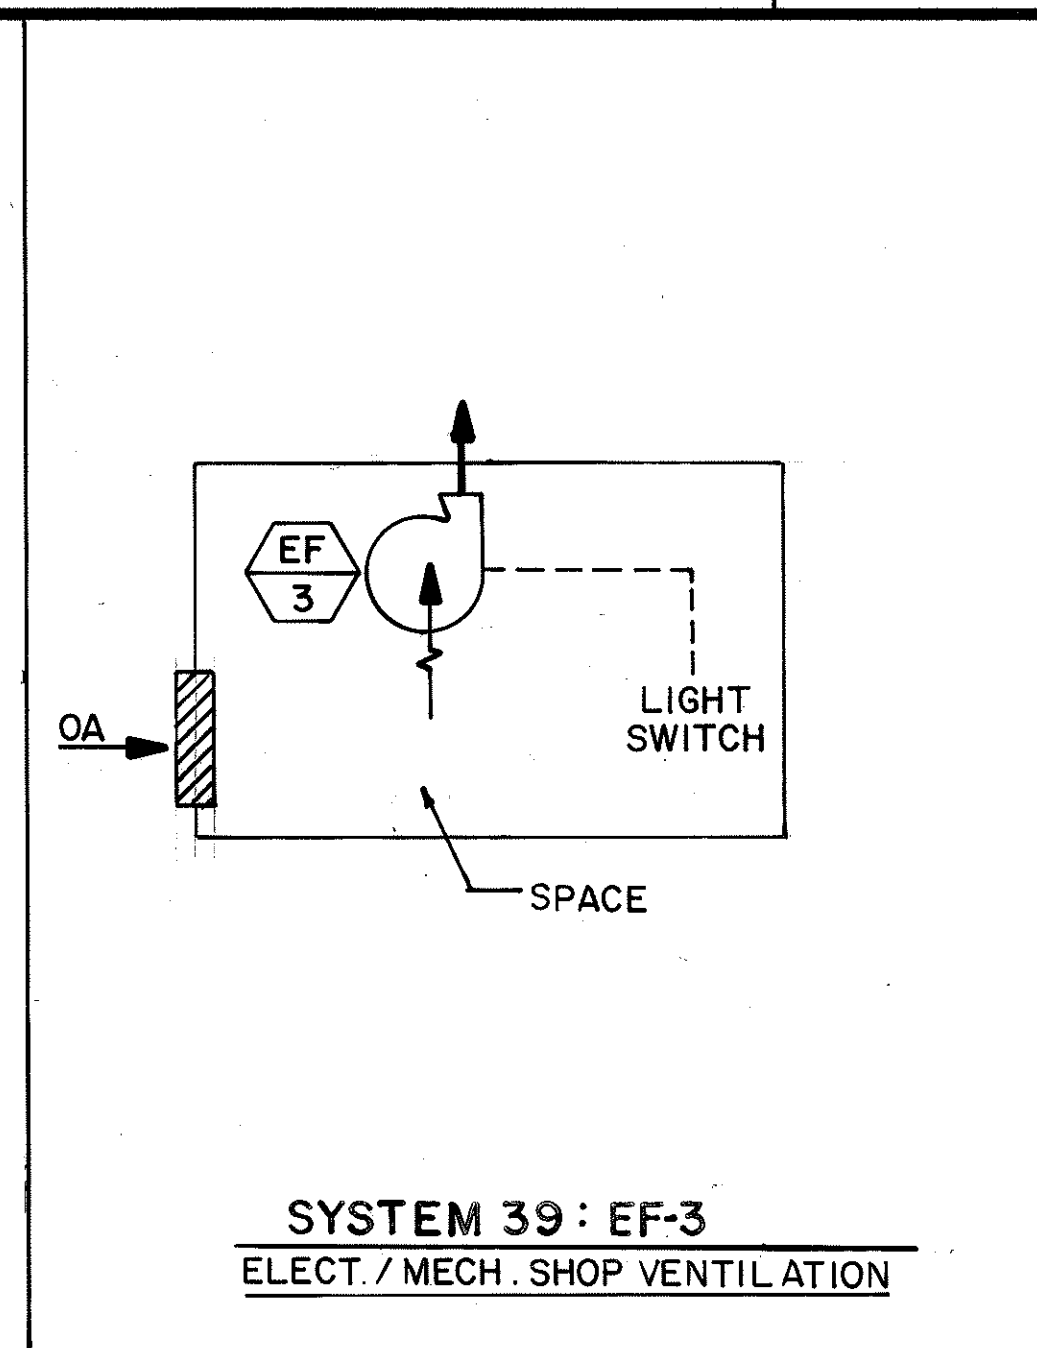


SYSTEM 39: EF-3
ELECT./MECH. SHOP VENTILATION

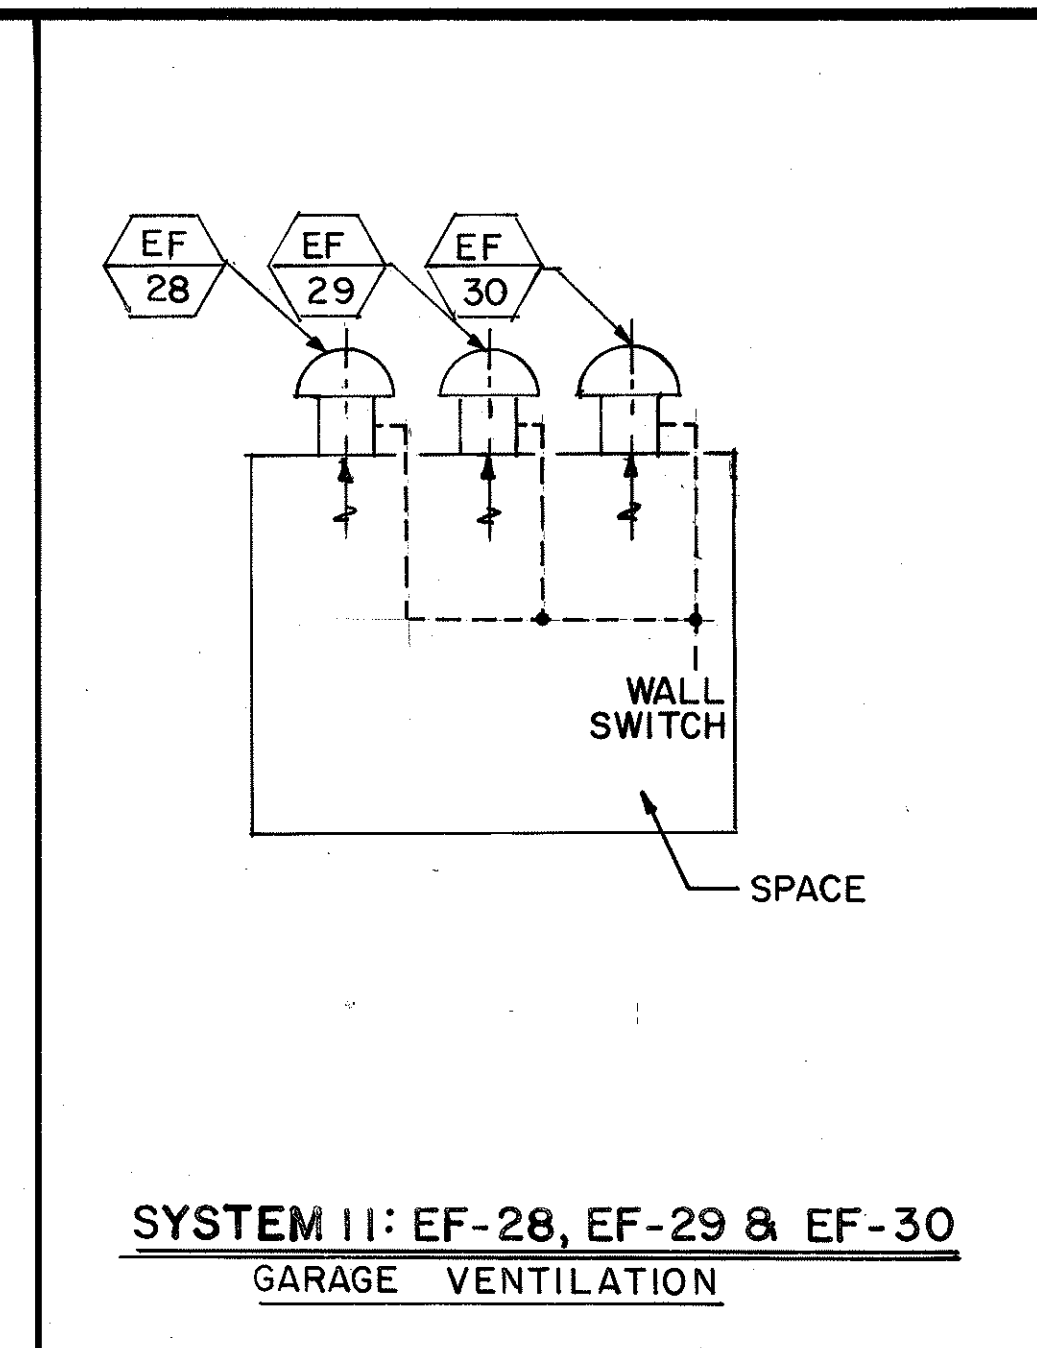


SYSTEM 11: EF-28, EF-29 & EF-30
GARAGE VENTILATION

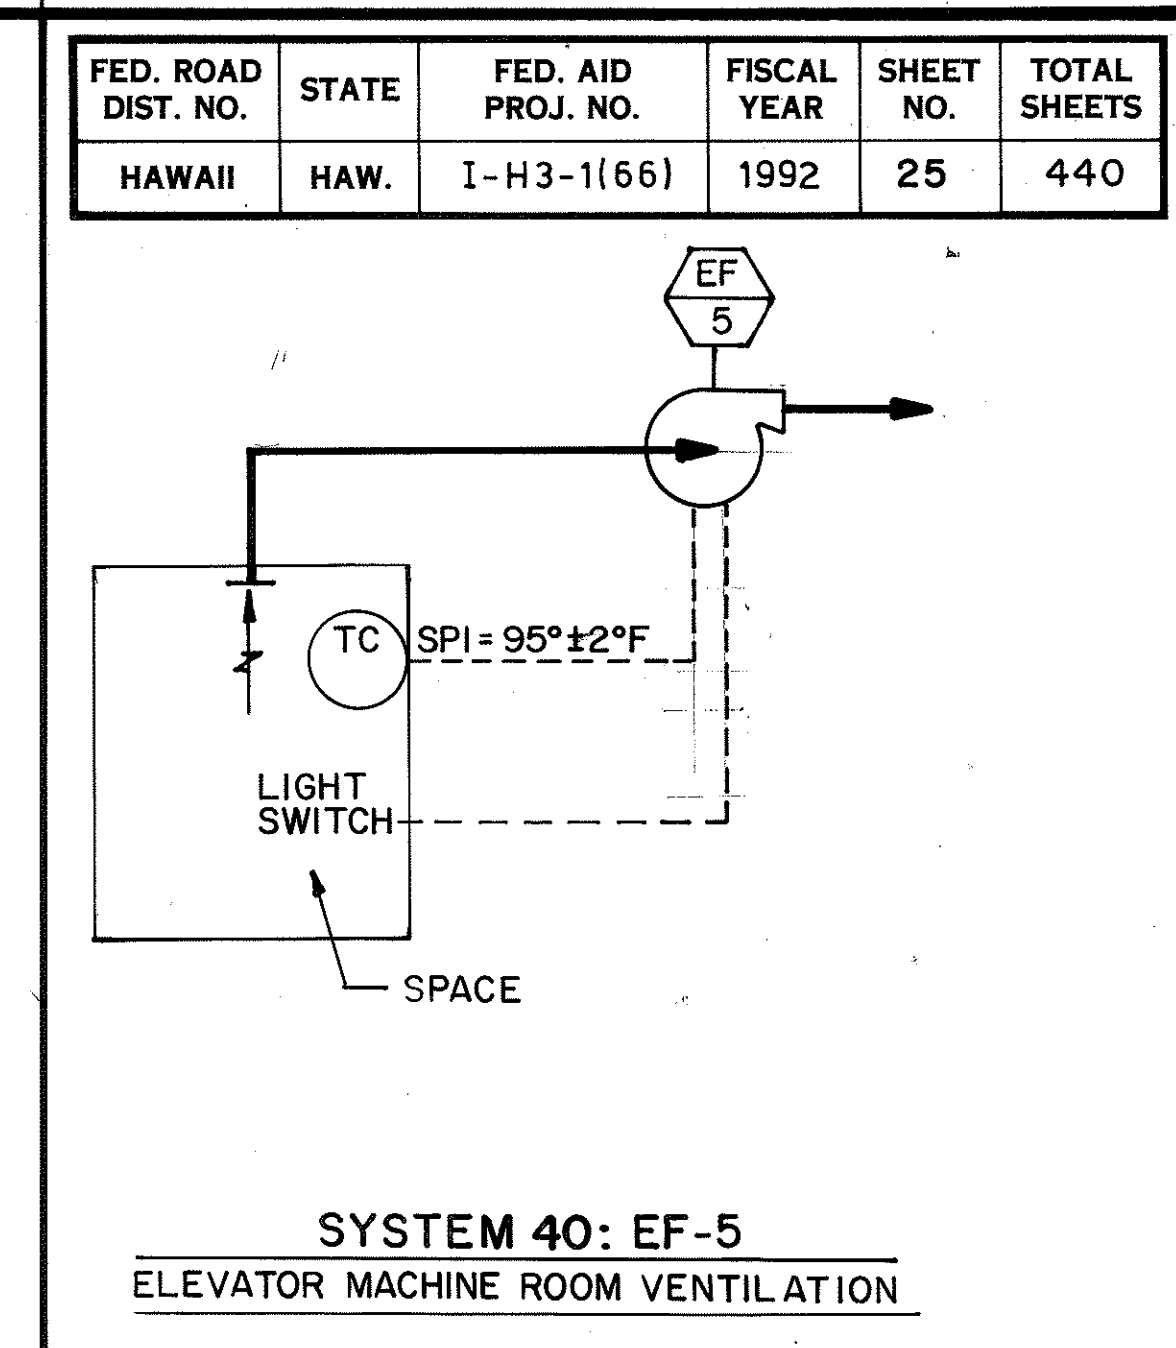


SYSTEM 40: EF-5
ELEVATOR MACHINE ROOM VENTILATION

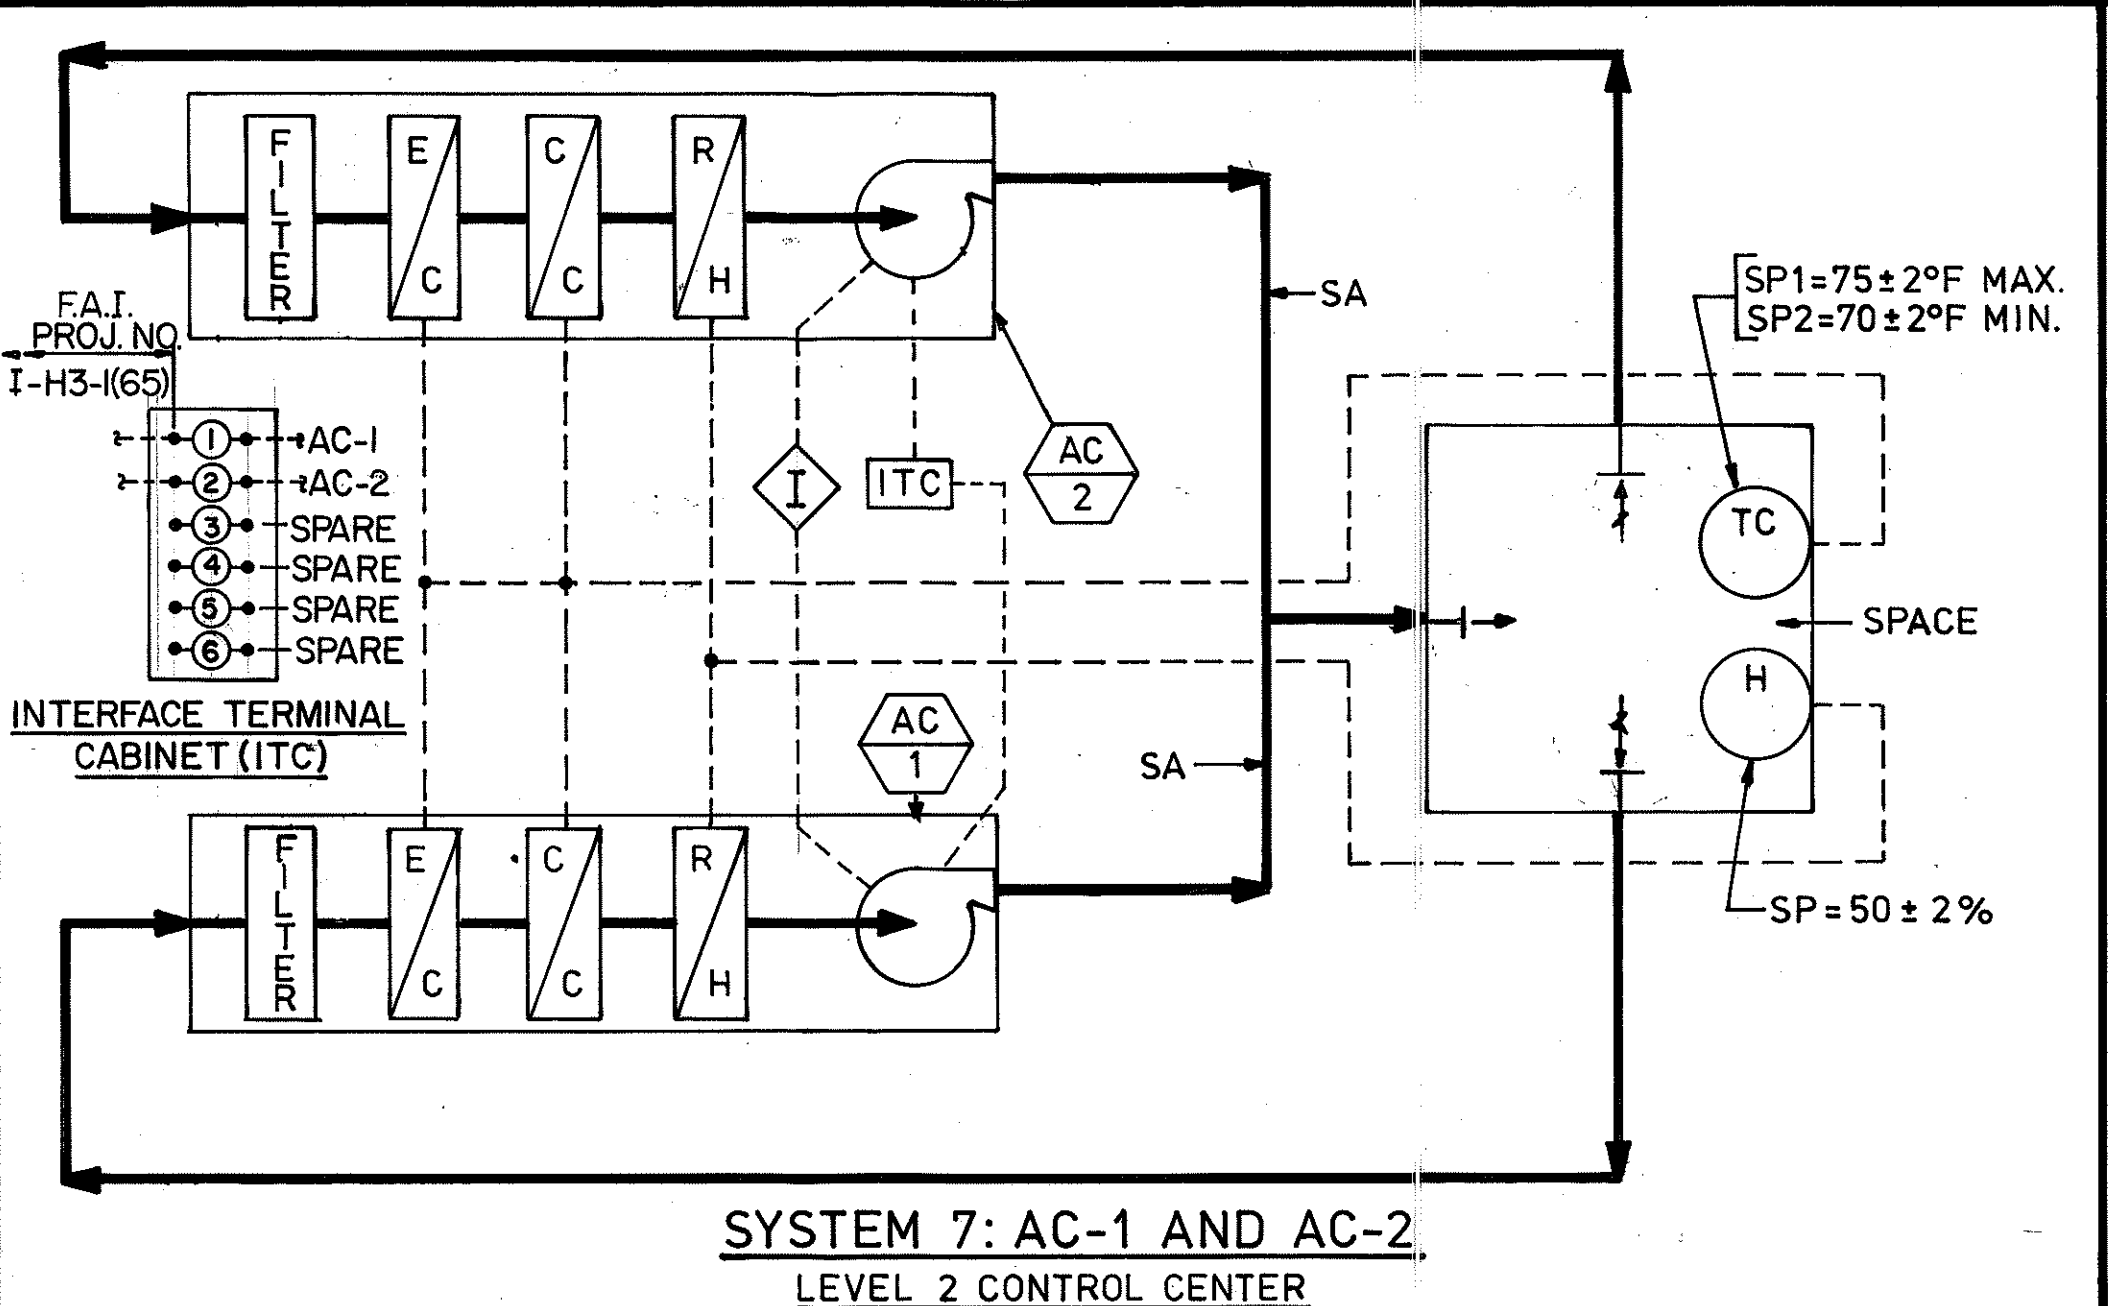


SYSTEM 7: AC-1 AND AC-2
LEVEL 2 CONTROL CENTER

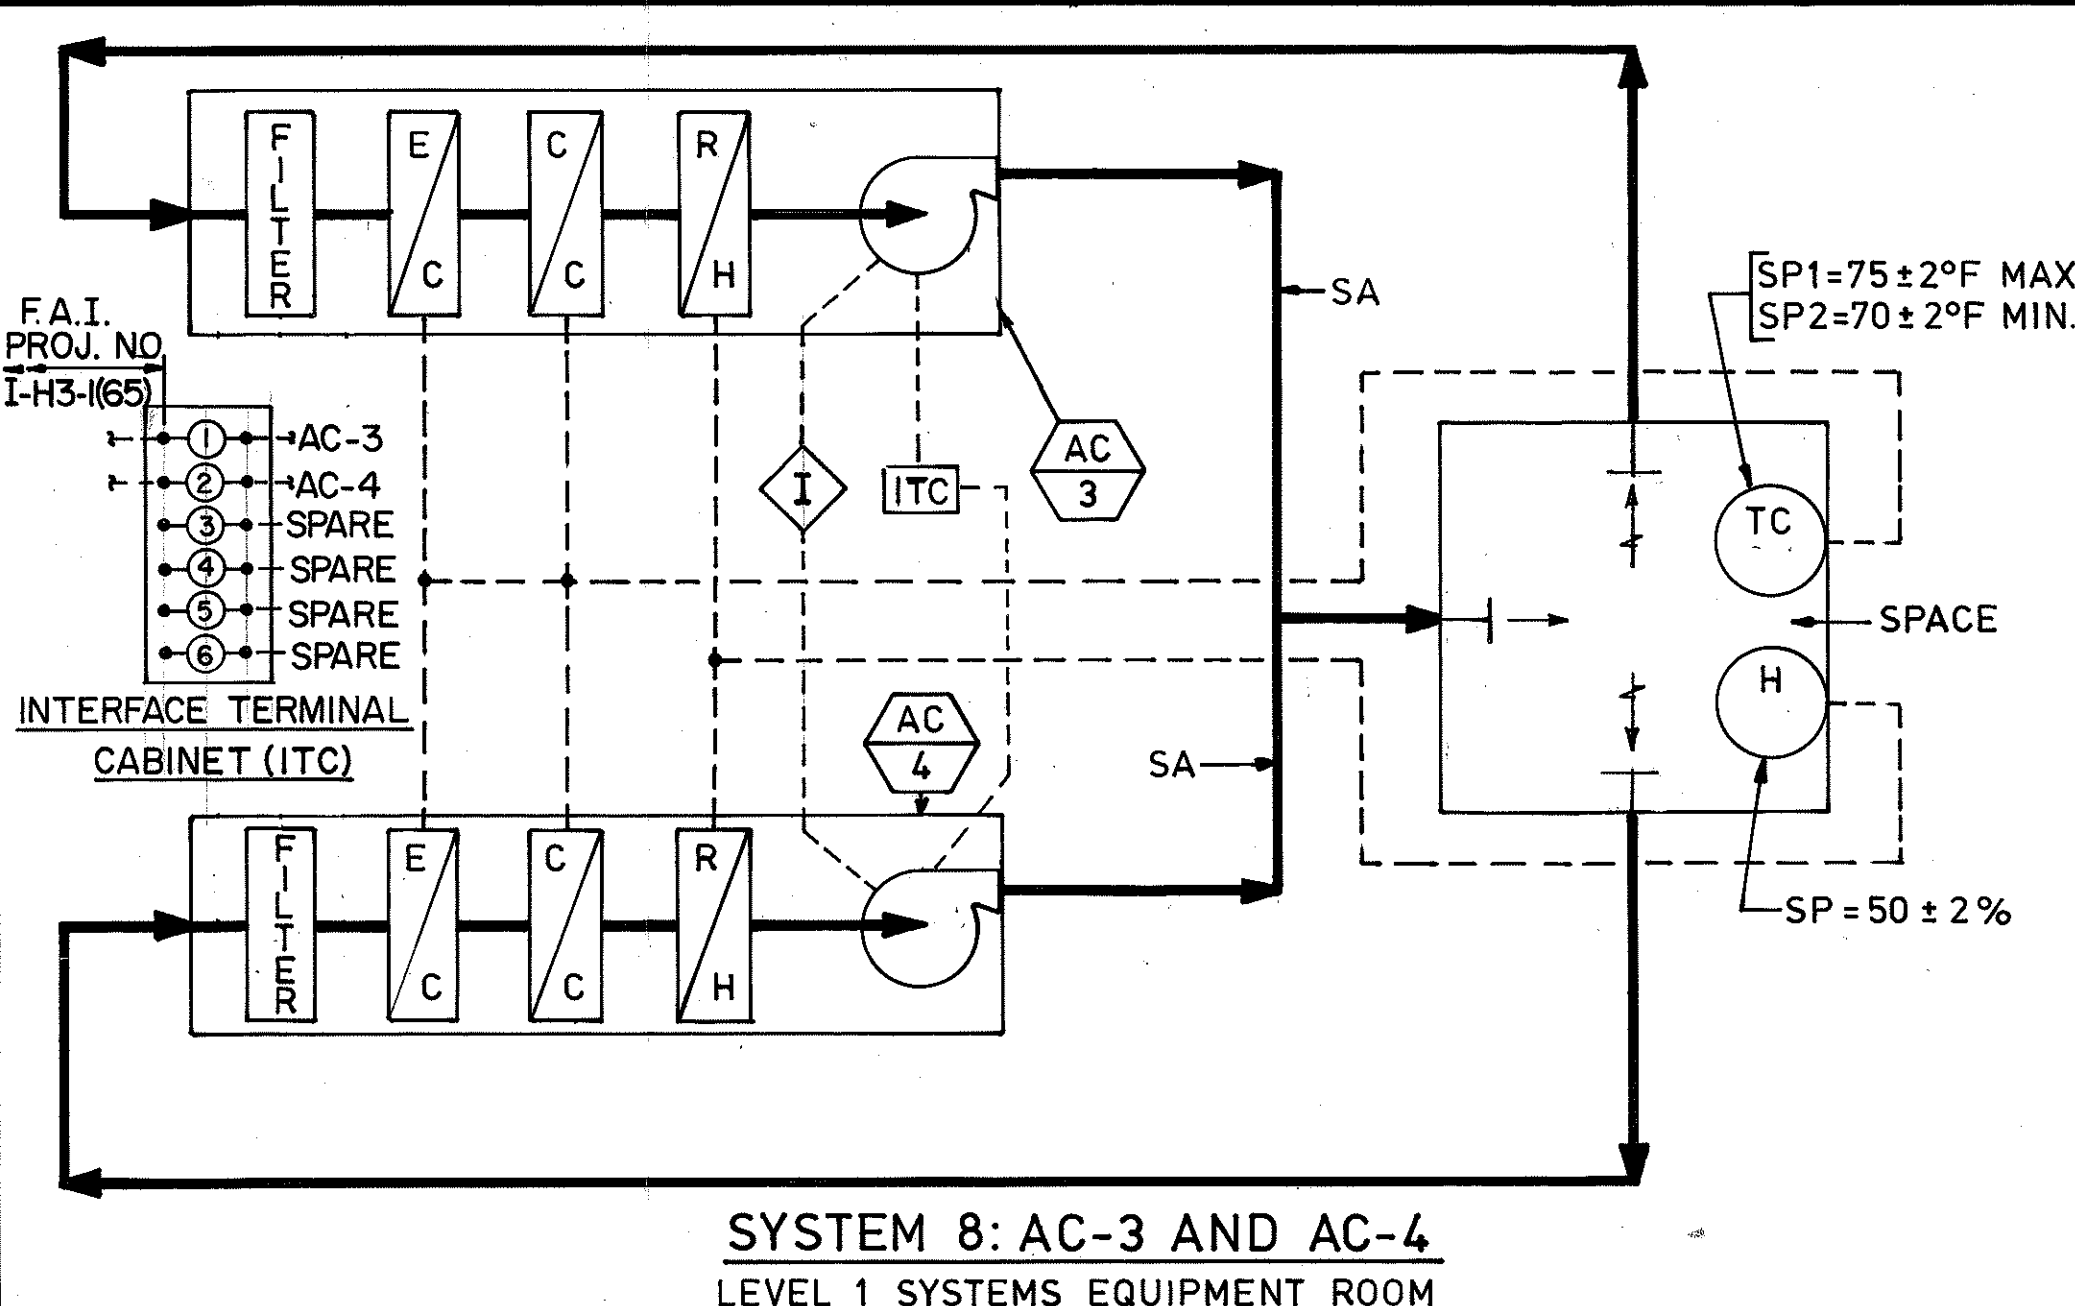


SYSTEM 8: AC-3 AND AC-4
LEVEL 1 SYSTEMS EQUIPMENT ROOM

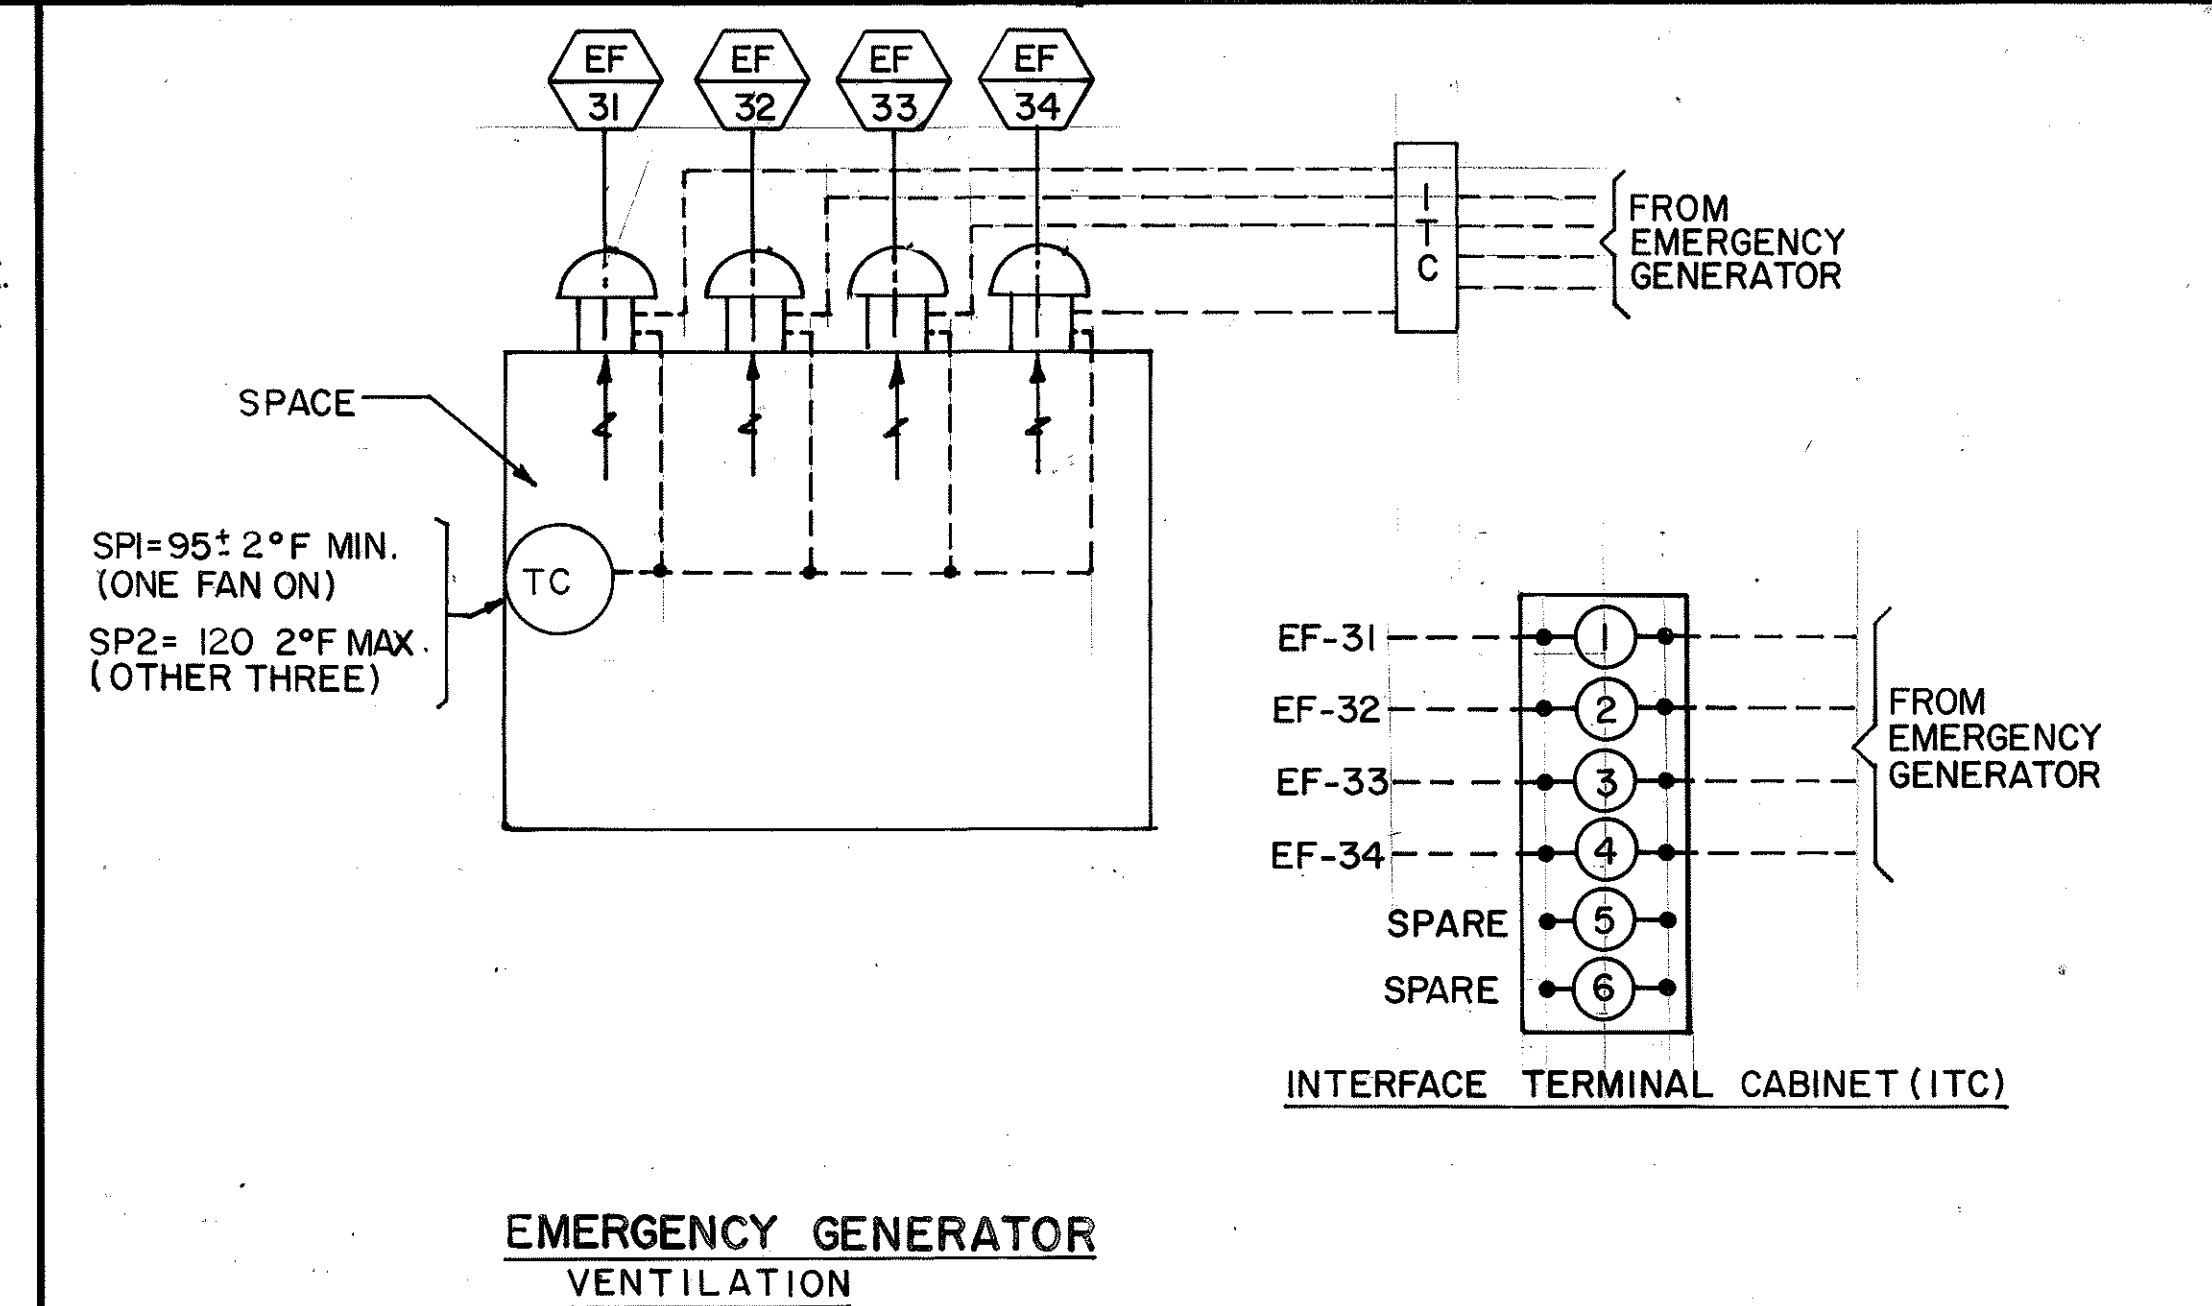


EMERGENCY GENERATOR
VENTILATION

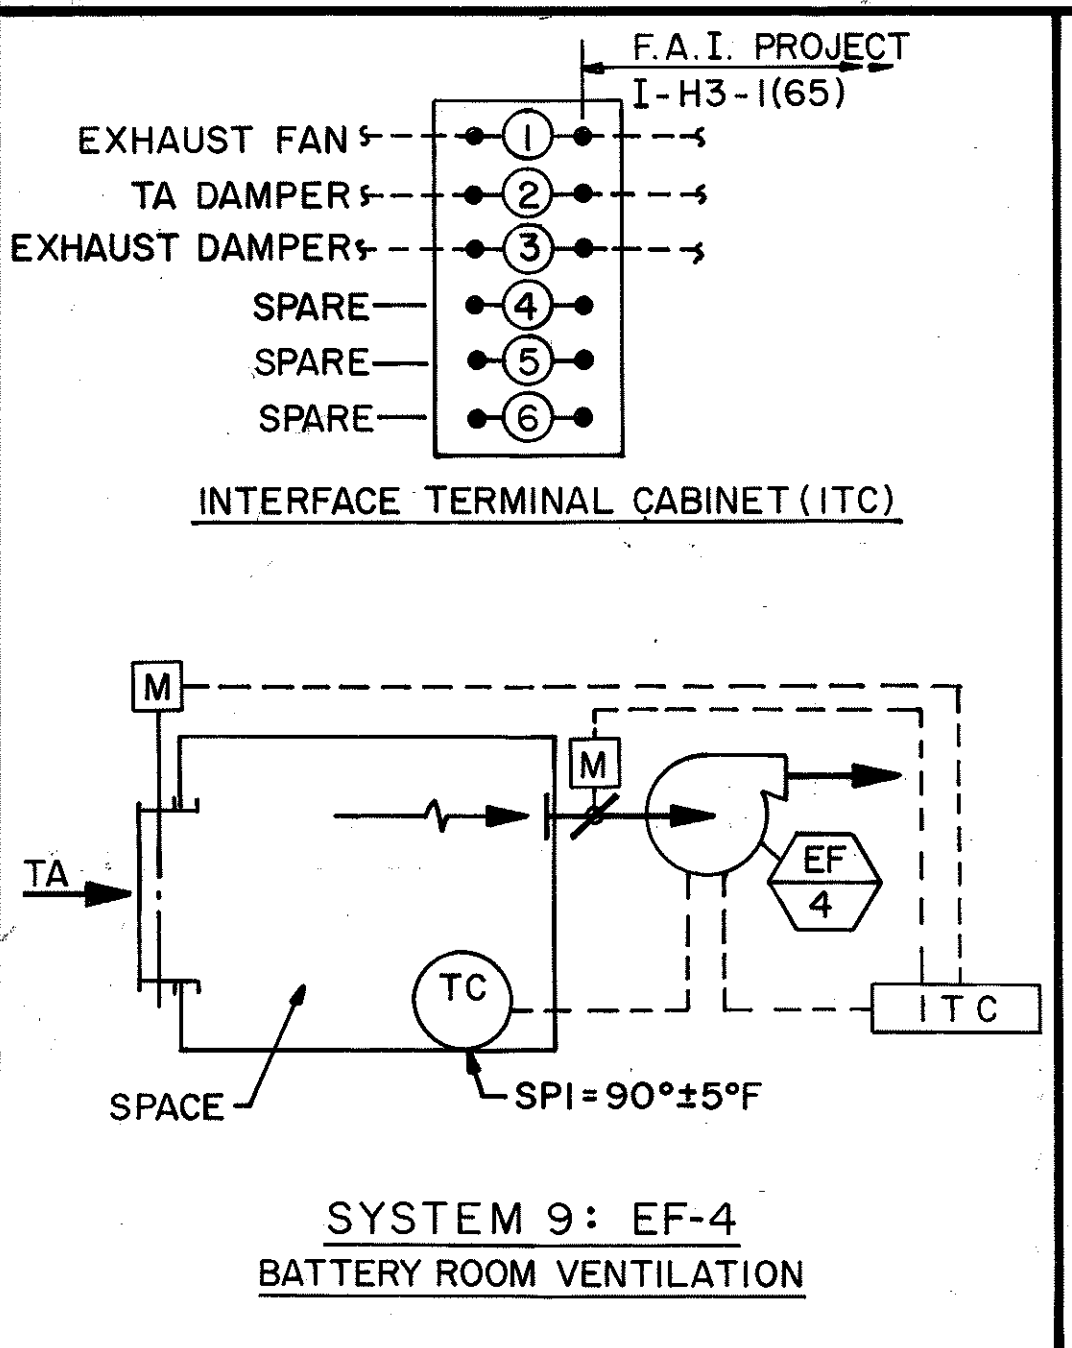


SYSTEM 9: EF-4
BATTERY ROOM VENTILATION

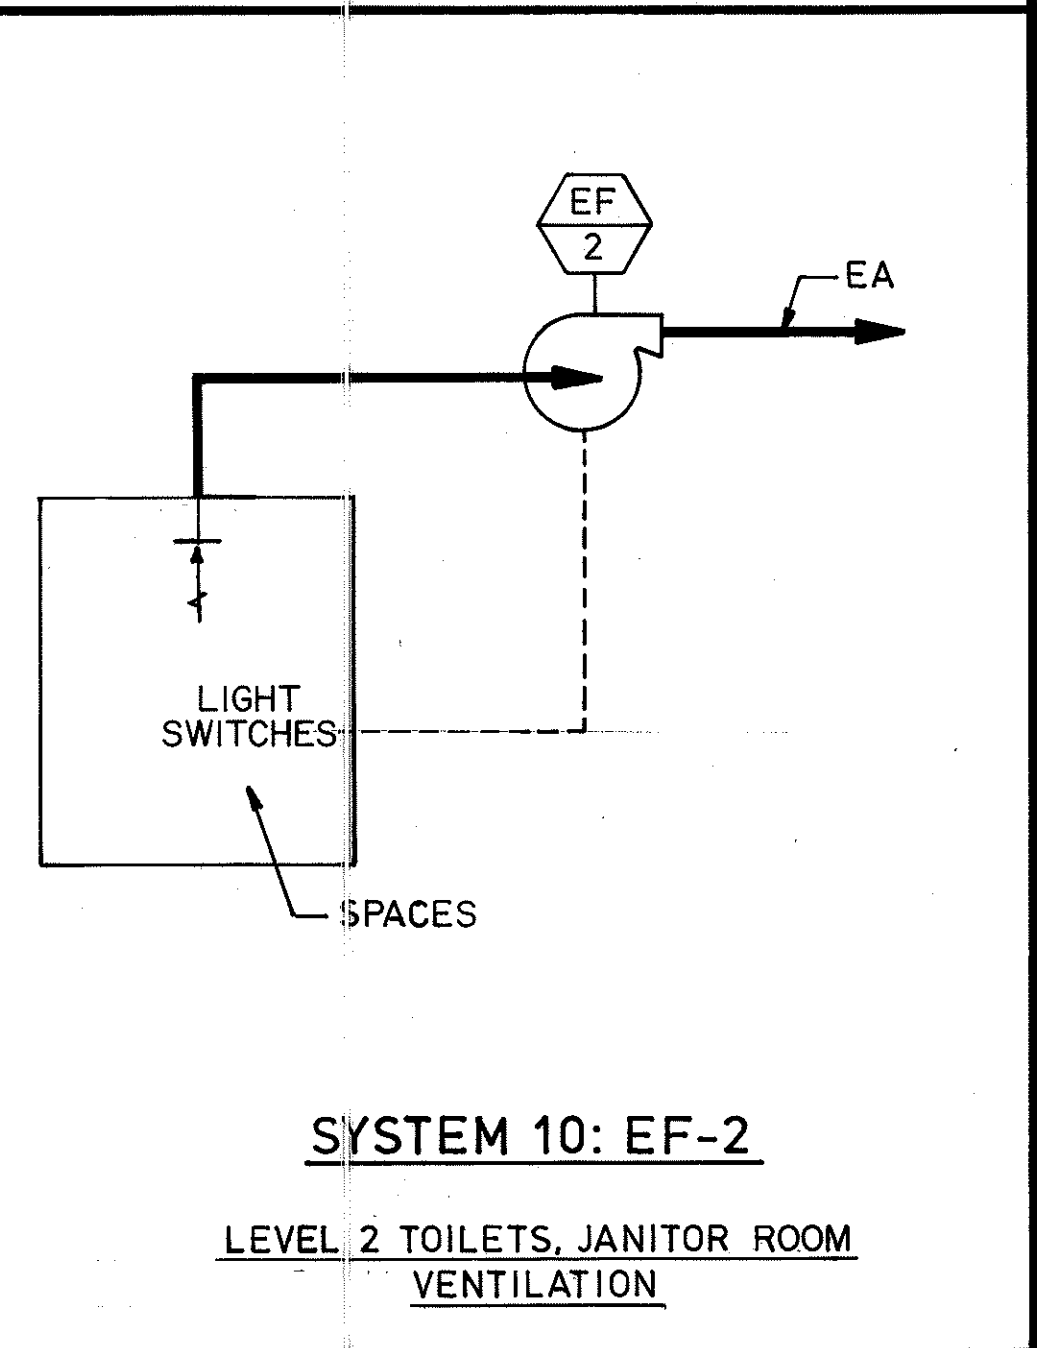


SYSTEM 10: EF-2
LEVEL 2 TOILETS, JANITOR ROOM VENTILATION

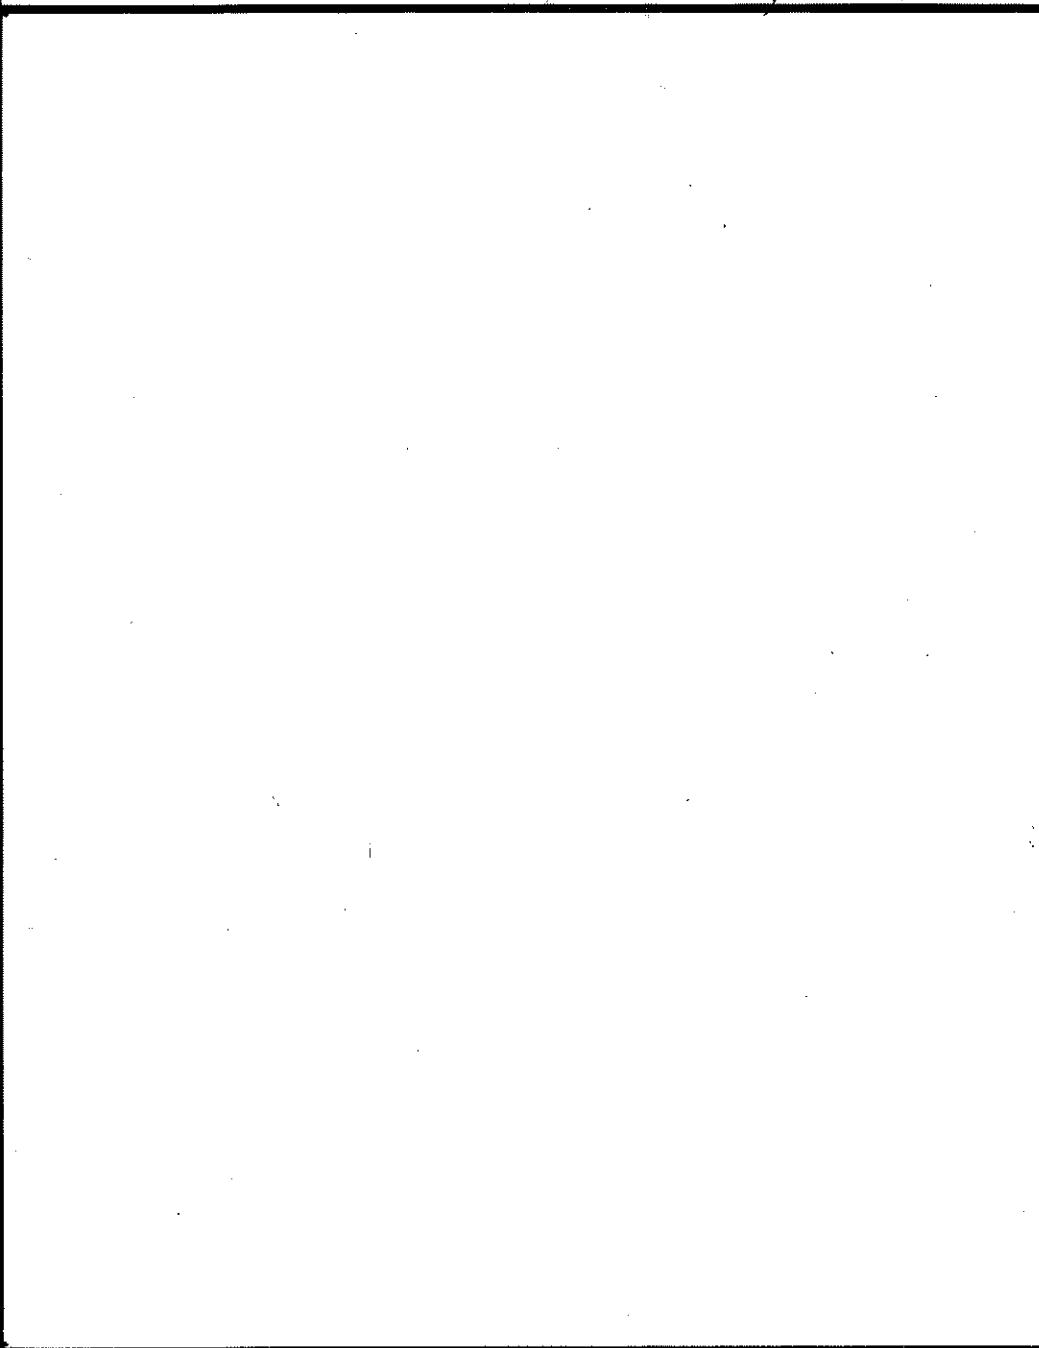

SYSTEM 13: EF-6
CLEAN AGENT AUTOMATIC FIRE SUPPRESSION SYSTEM EXHAUST

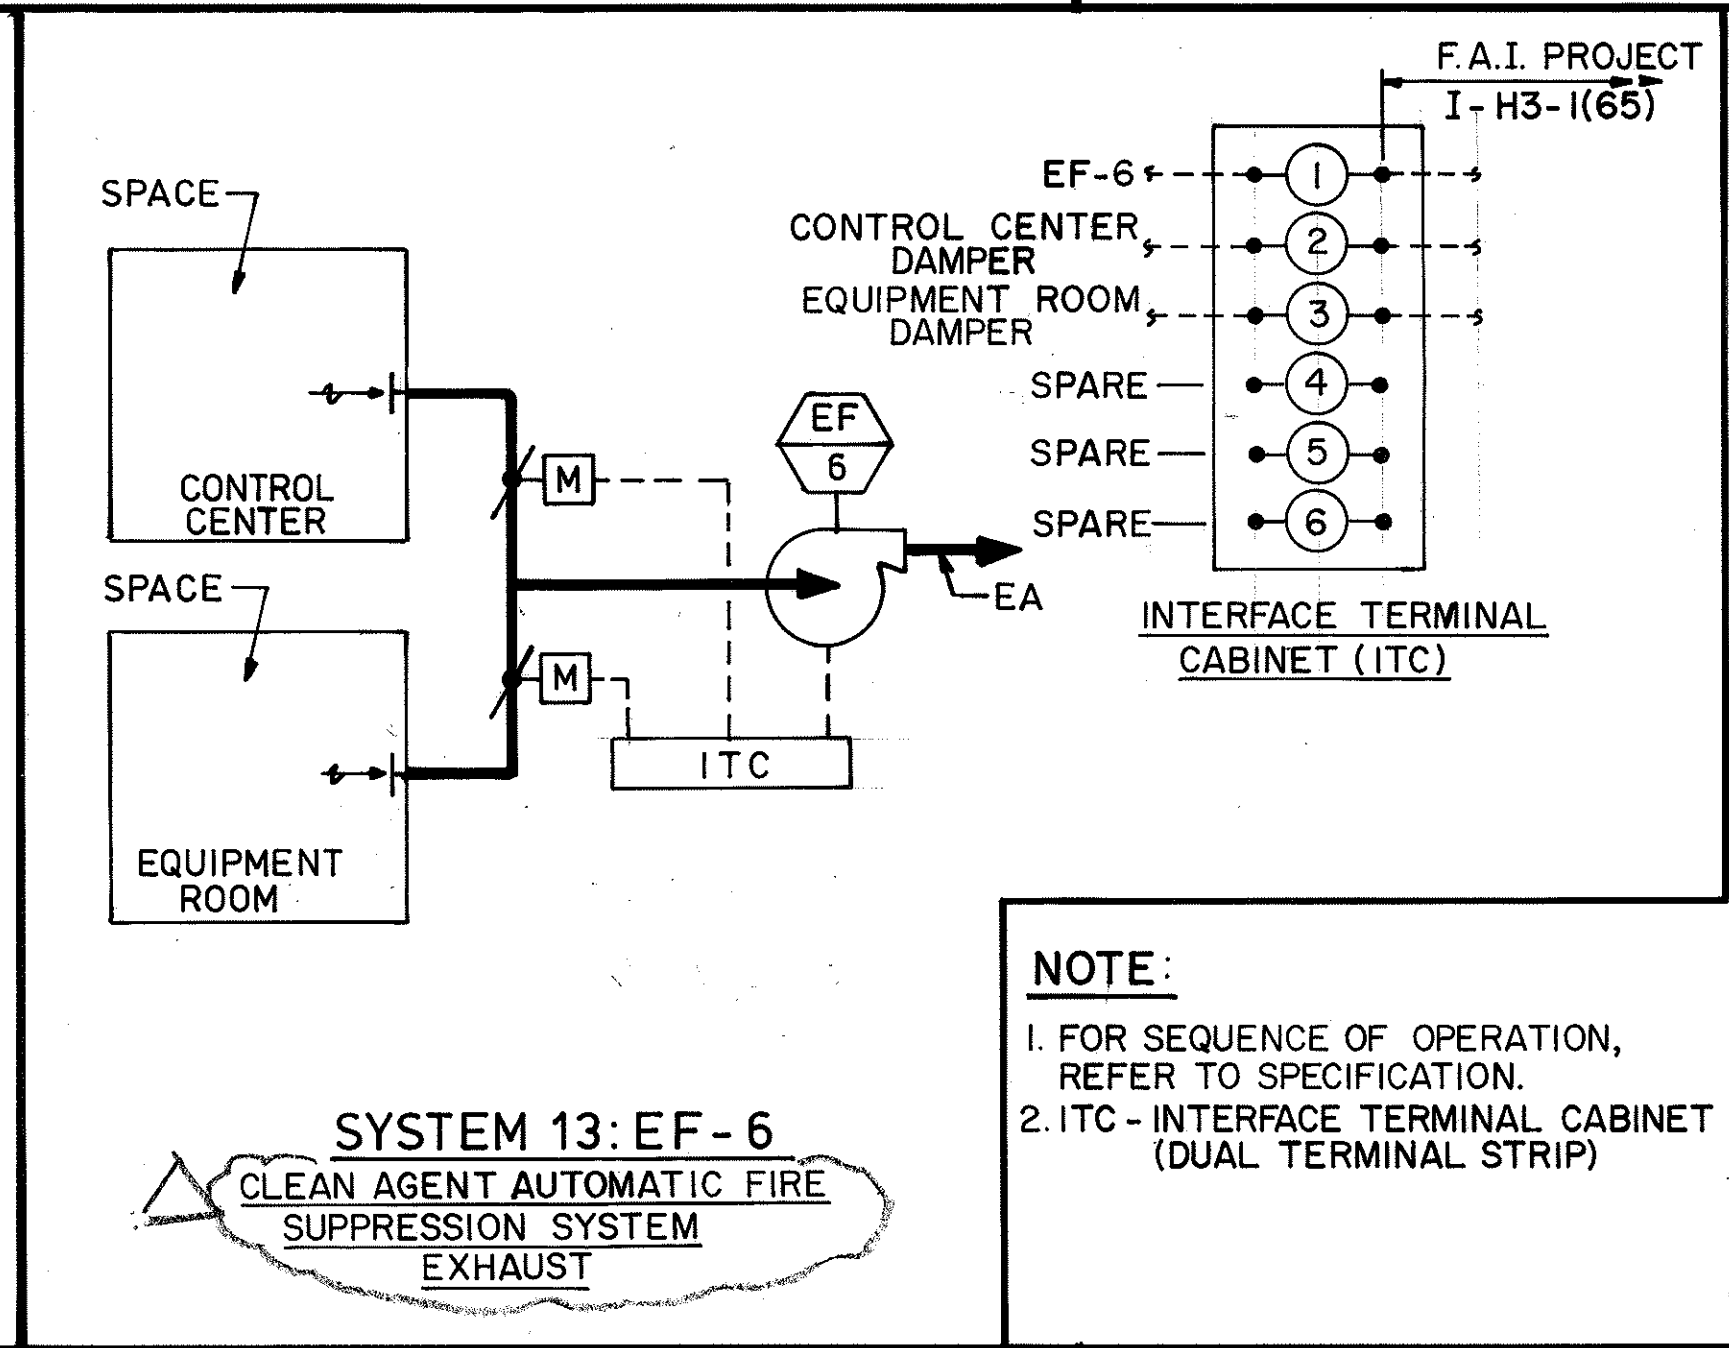


NOTE:
1. FOR SEQUENCE OF OPERATION, REFER TO SPECIFICATION.
2. ITC - INTERFACE TERMINAL CABINET (DUAL TERMINAL STRIP)

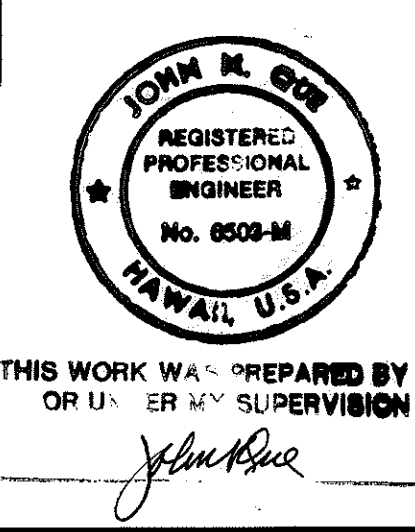



DATE	1/25/94
REVISION	REV. 'SYSTEM 13: EF-6' DESCRIPTION PER DCN 66-034
STATE OF HAWAII DEPARTMENT OF TRANSPORTATION HIGHWAYS DIVISION CONTROL BUILDING HVAC CONTROL DIAGRAMS STANDARDS INTERSTATE ROUTE H-3 F.A.I. PROJ. NO. I-H3-1(66) SCALE: NONE DATE: APR. 1992 SHEET NO. M15 OF 28 SHEETS	

DATE	9/05/89
DESIGNED BY	D. E. DRYDEN
TRACED BY	A. H. PORTIER
NOTED BY	J. N. QUE
CHECKED BY	
ORIGINAL PLAN	
NO.	


FED. ROAD DIST. NO.	STATE	FED. AID PROJ. NO.	FISCAL YEAR	SHEET NO.	TOTAL SHEET
HAWAII	HAW.	I-H3 - I(66)	1992	26	440

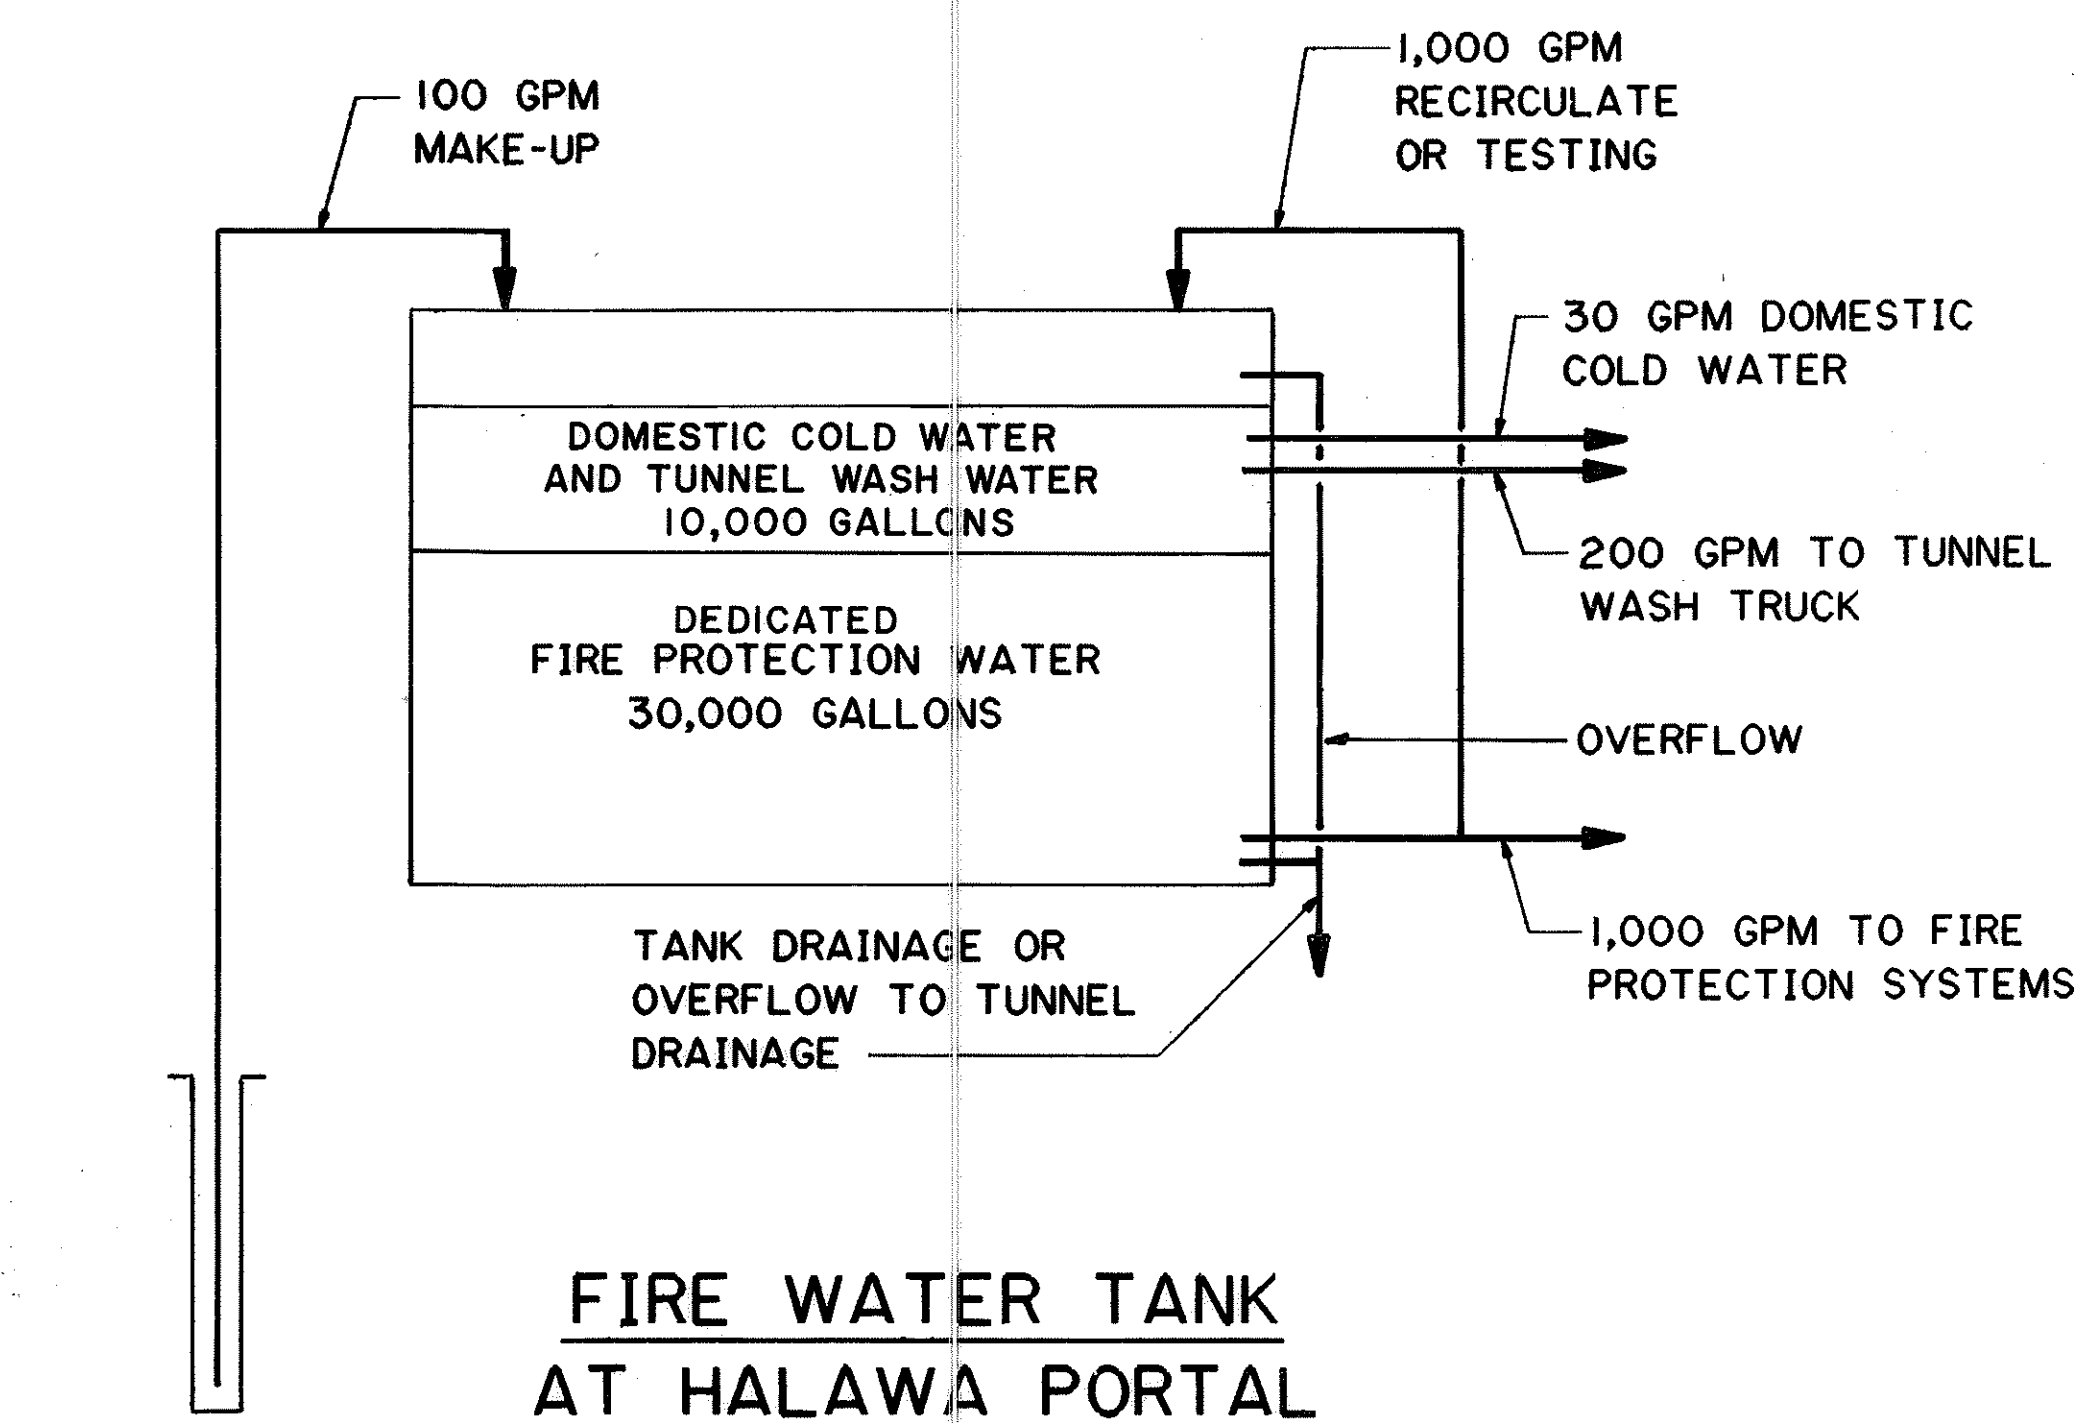

WELL NO. 1

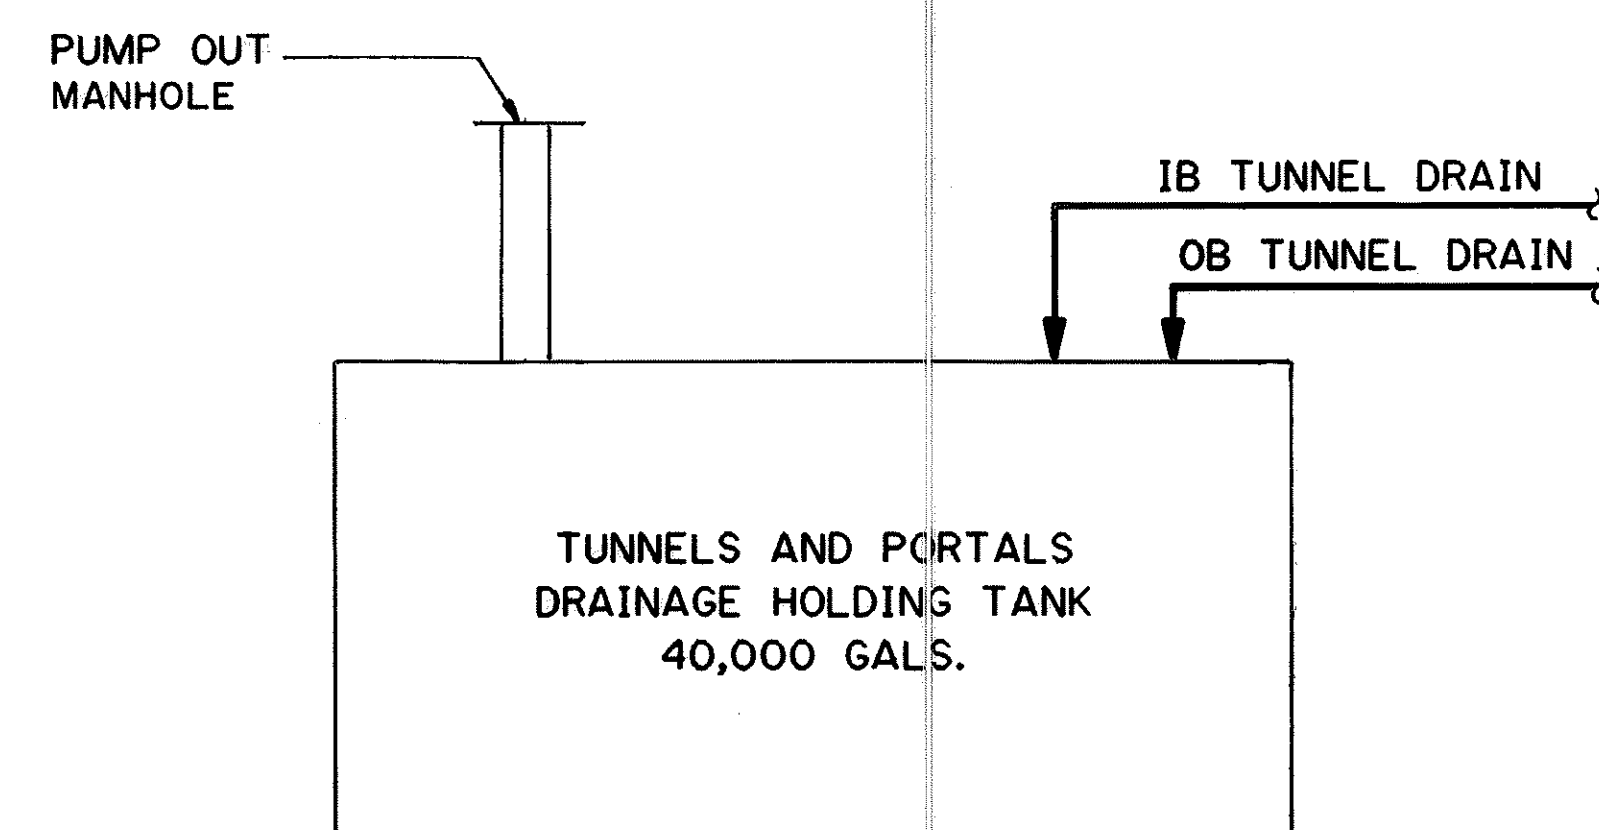
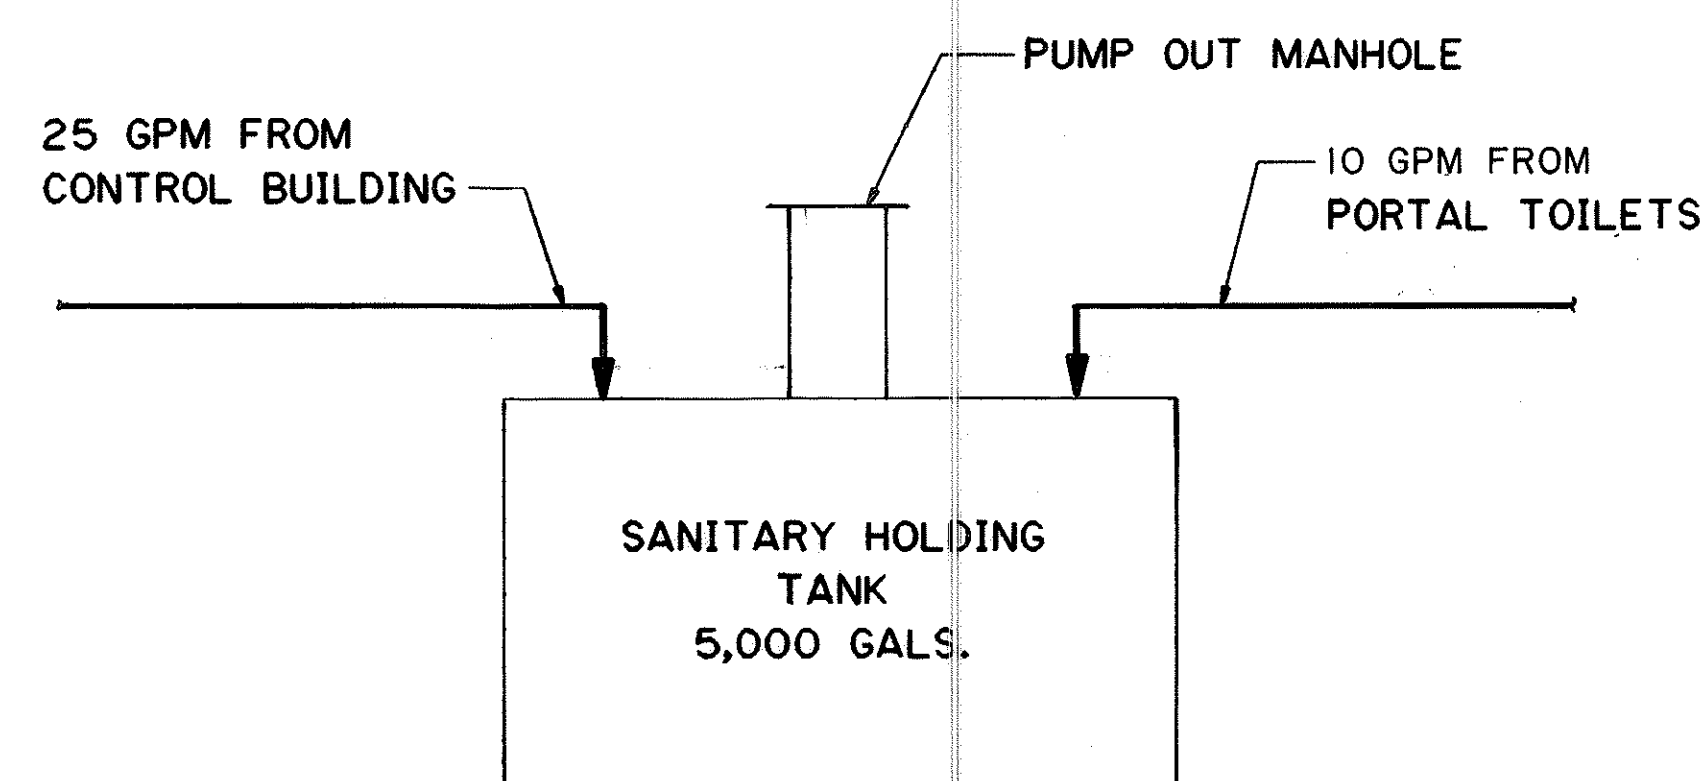


HALAWA APPROACH

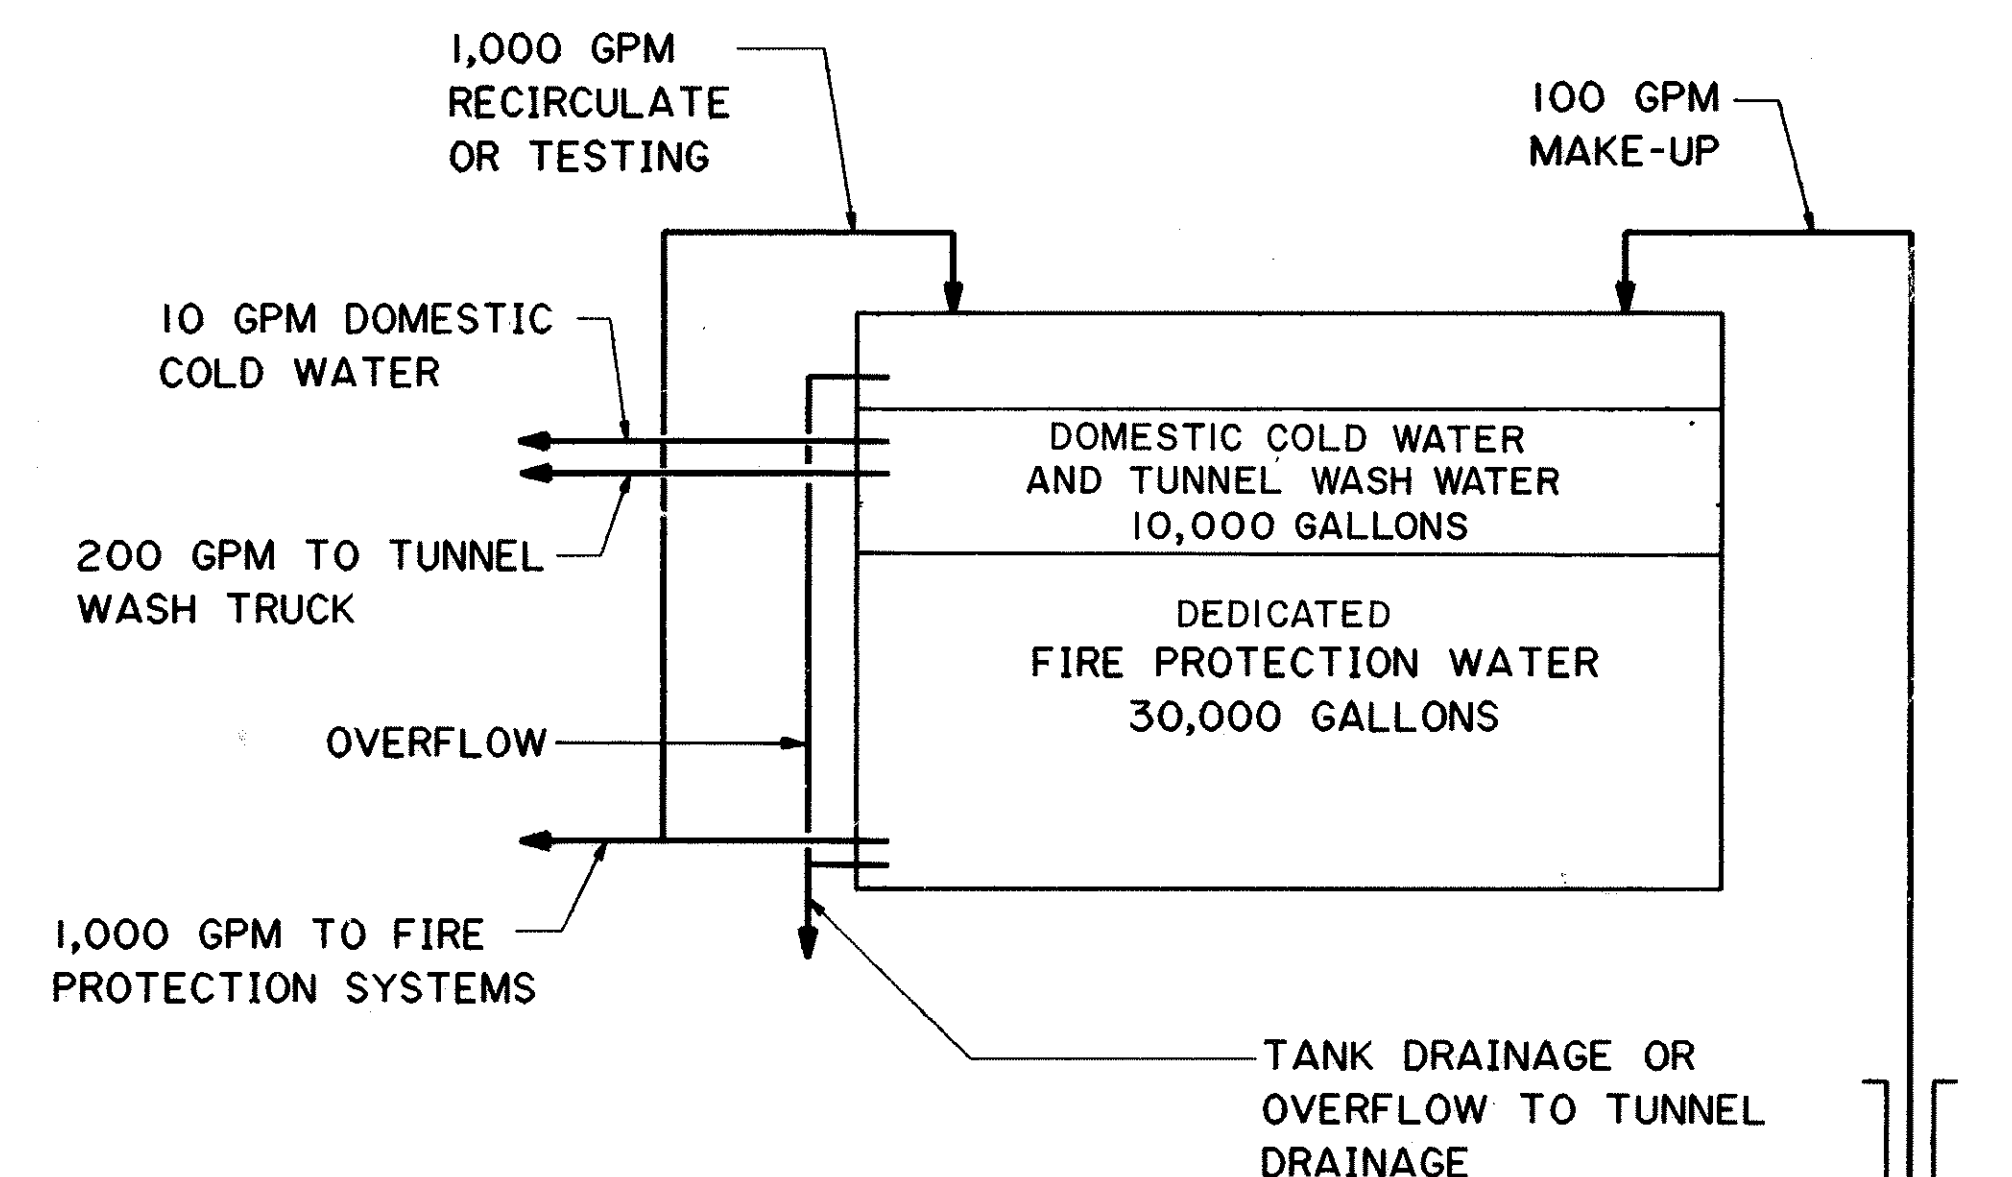

FIRE WATER TANK AT HAIKU PORTAL

WELL NO. 2

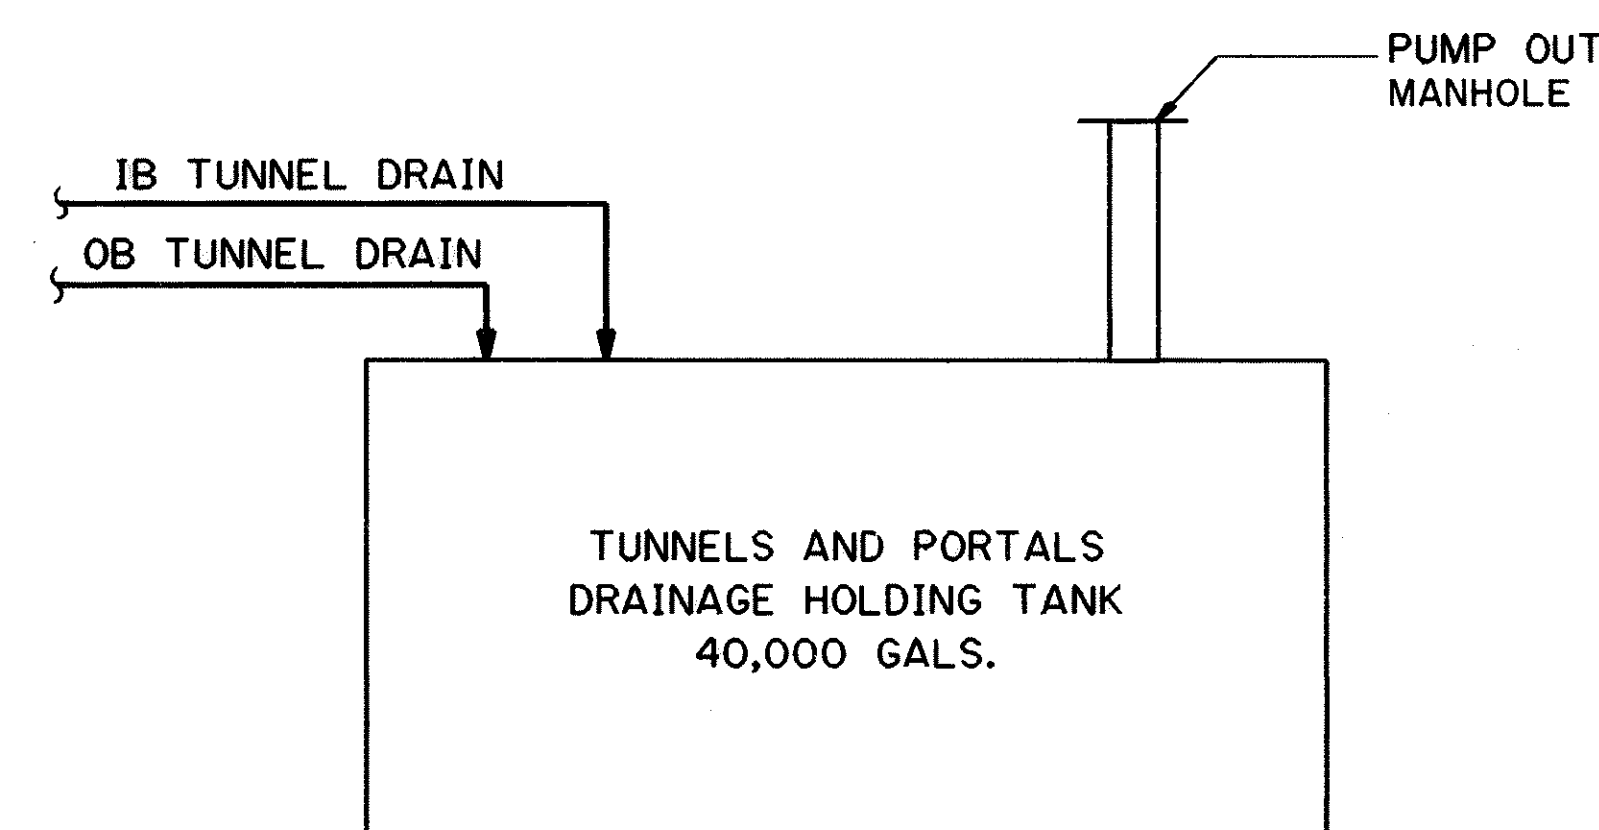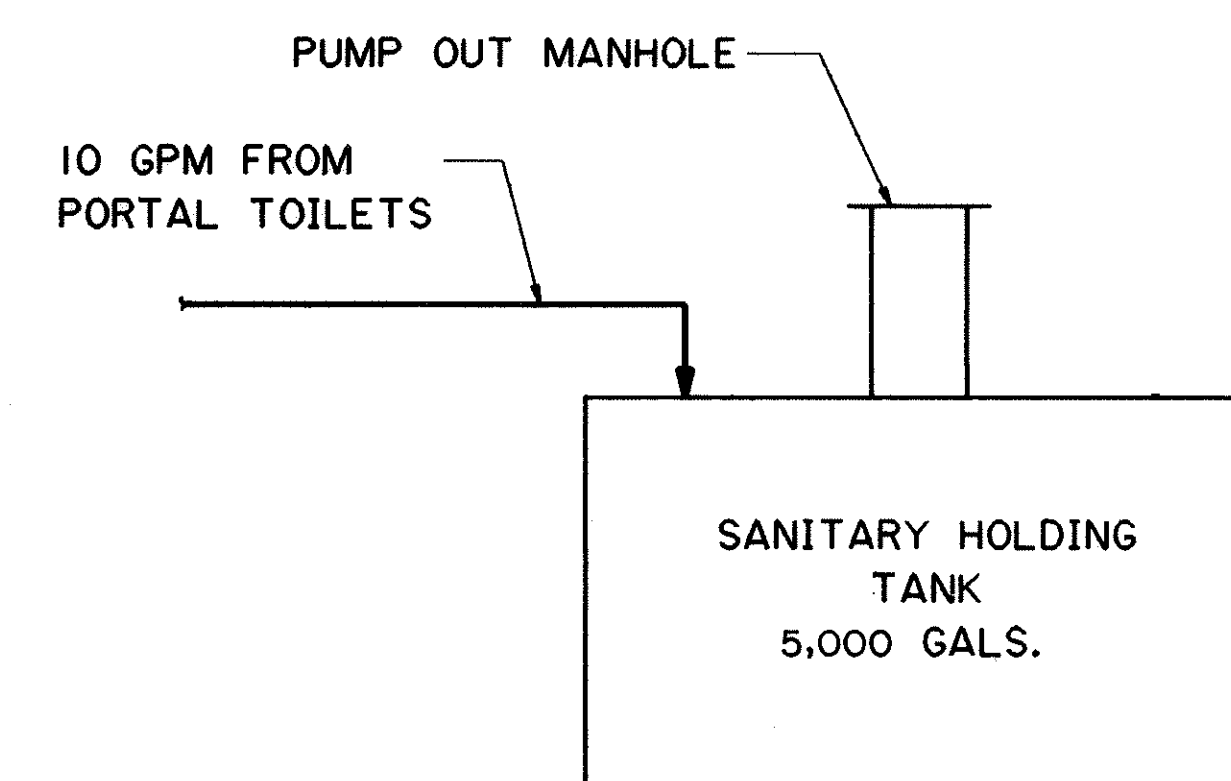

HAIKU APPROACH



THIS WORK WAS PREPARED BY ME
OR UNDER MY SUPERVISION

STATE OF HAWAII
DEPARTMENT OF TRANSPORTATION
HIGHWAYS DIVISION

PLUMBING

WATER BALANCE DIAGRAM

STANDARDS

INTERSTATE ROUTE H-3

F.A.I. PROJ. NO. I-H3-I(66)

SCALE: NONE
DATE: APR. 1992

SHEET NO.
M16
OF 28
SHEETS


HAIKU PORTALS



SCALE: NONE DATE: APR 1992
SHEET NO. M17 OF 28 SHEETS

ORIGINAL PLAN	SURVEY PLOTTED BY	DATE
	DRAWN BY B. F. BUNYI	6/12/89
NOTE: BOOK	TRACED BY	
	DESIGNED BY P. L. LALOUE	6/4/89
	QUANTITIES BY	
NO	CHECKED BY J. N. QUE	06/01/90

FED. ROAD DIST. NO.	STATE	FED. AID PROJ. NO.	FISCAL YEAR	SHEET NO.	TOTAL SHEETS
HAWAII	HAW.	I-H3-I(66)	1992	29	440

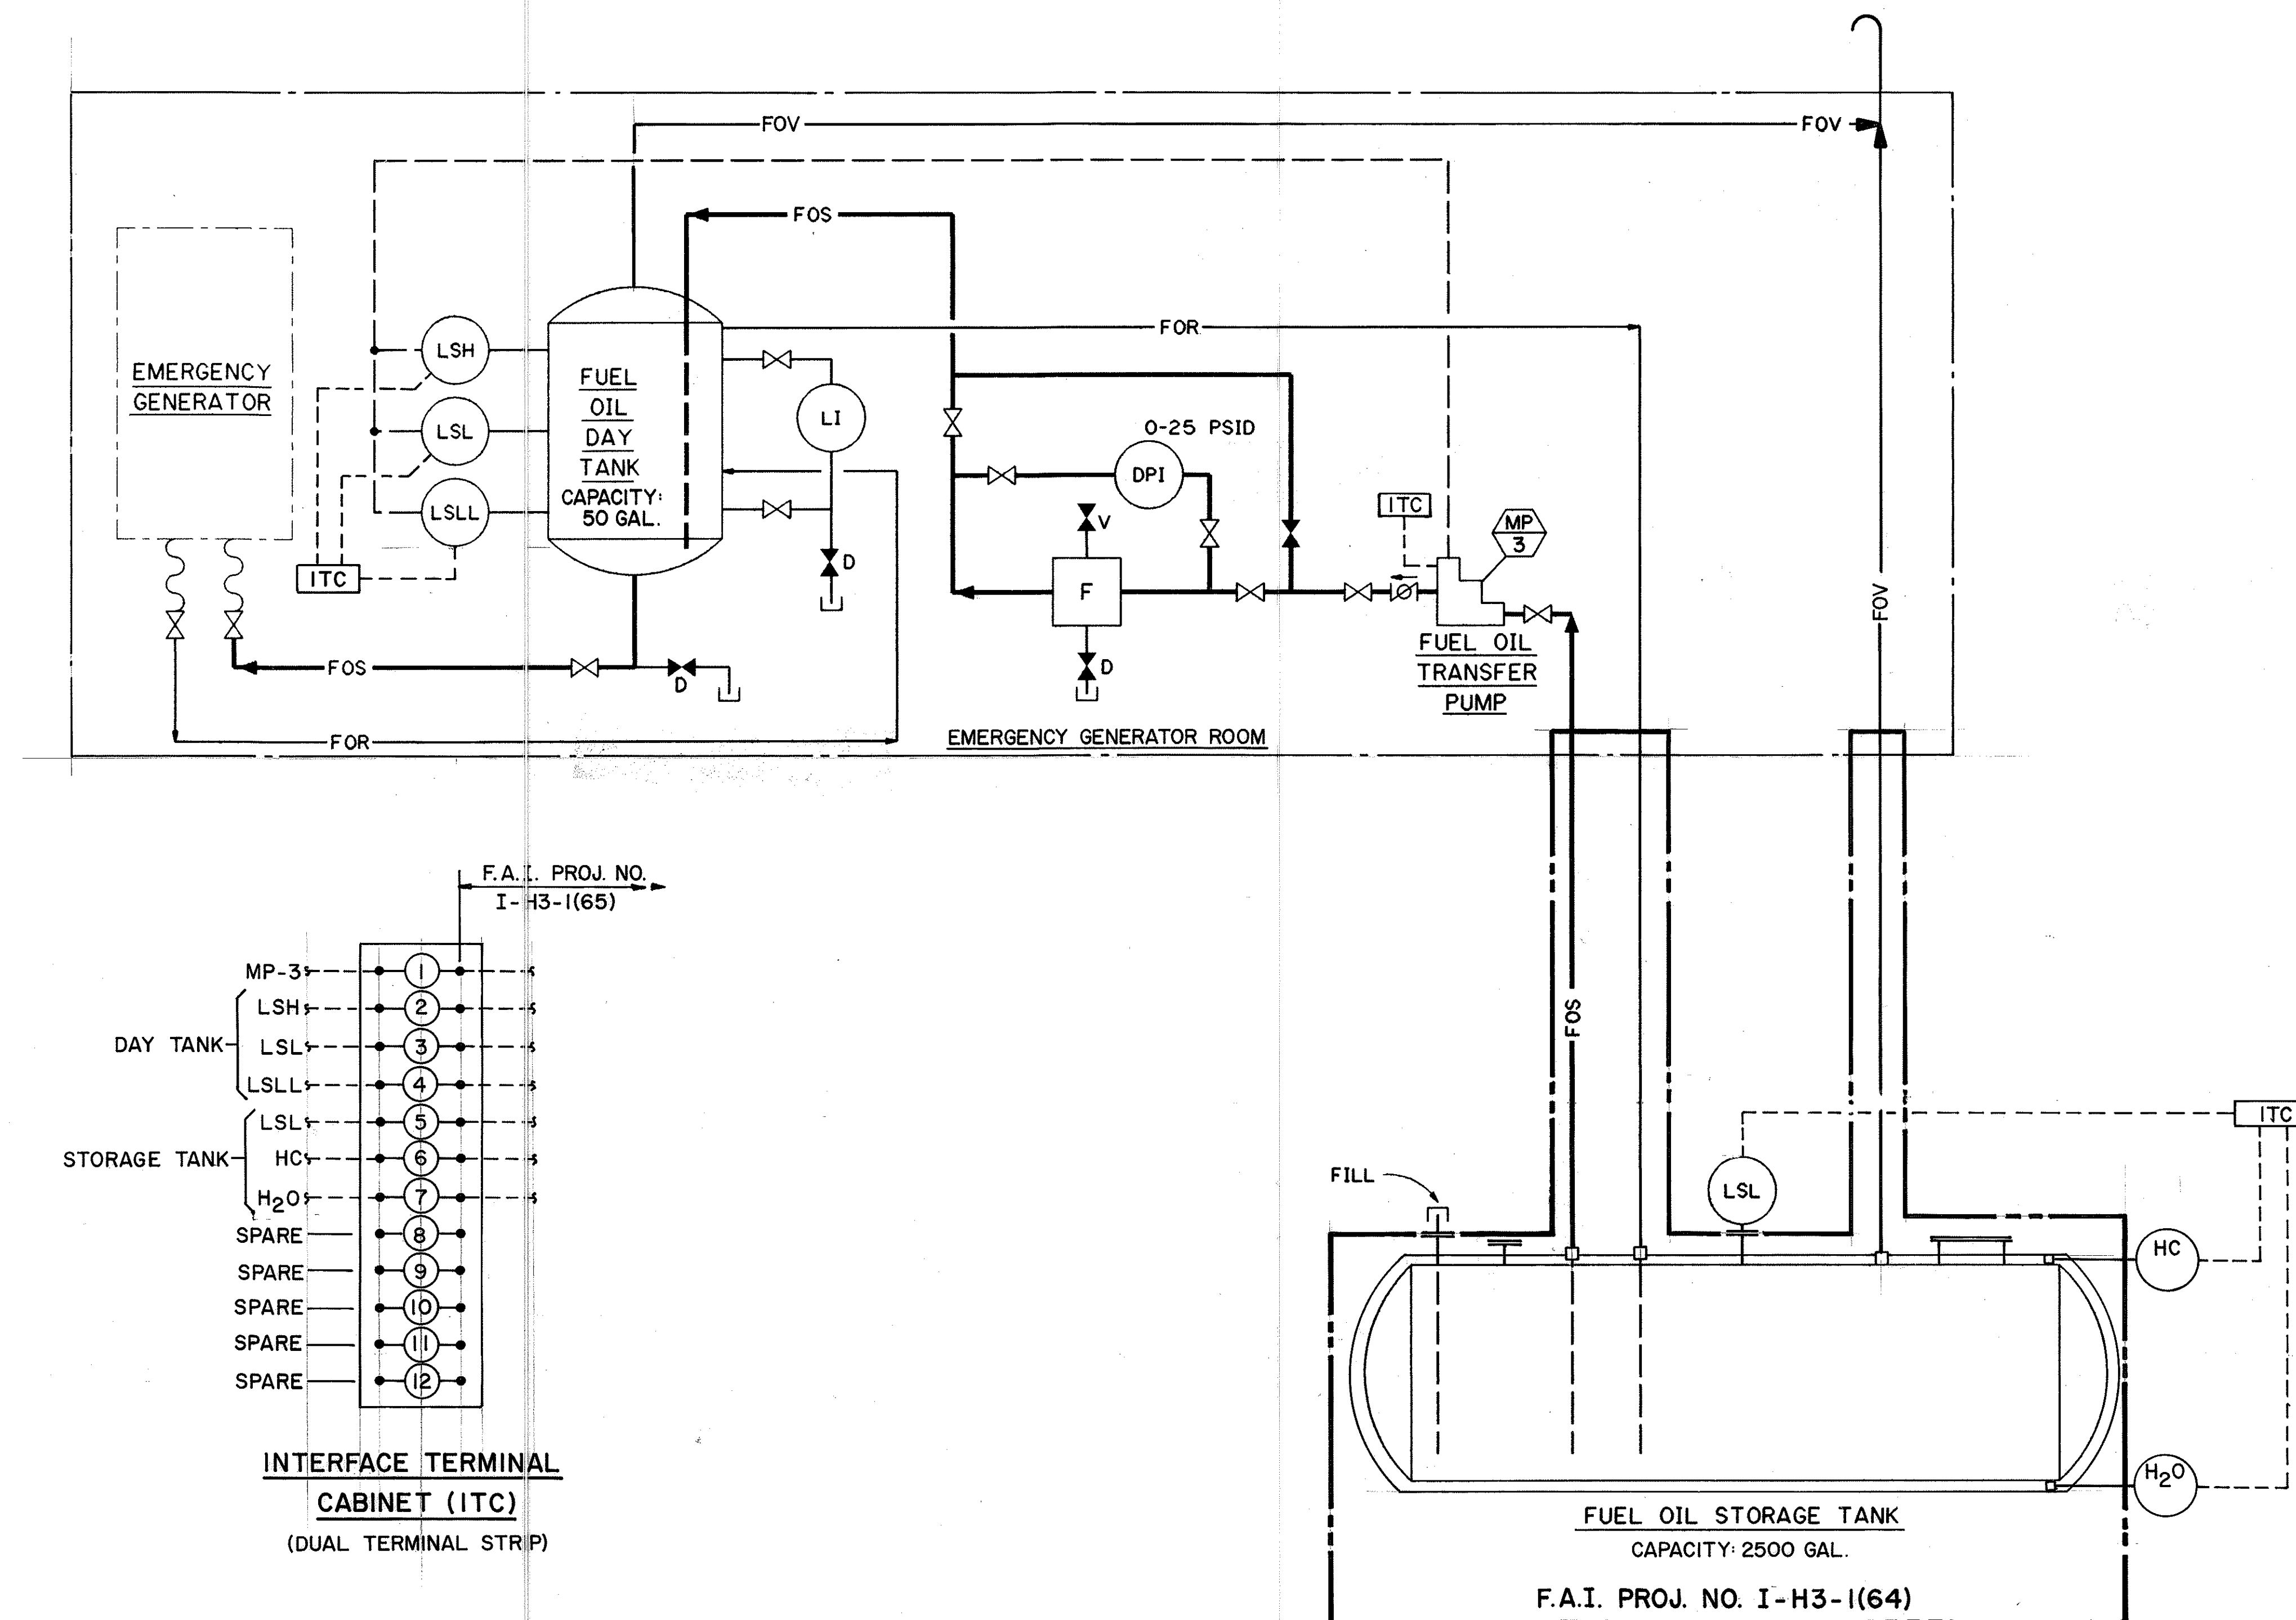

DATE	REVISION

STATE OF HAWAII
DEPARTMENT OF TRANSPORTATION
HIGHWAYS DIVISION

EMERGENCY GENERATOR

P 8 & I D

STANDARDS

INTERSTATE ROUTE H-3
F.A.I. PROJ. NO. I-H3-I(66)

SCALE: NONE DATE: APR 1992

SHEET NO. M19 OF 28 SHEETS





THIS WORK WAS PREPARED BY M
OR UNDER MY SUPERVISION

John Doe

FED. ROAD DIST. NO.	STATE	FED. AID PROJ. NO.	FISCAL YEAR	SHEET NO.	TOTAL SHEETS
HAWAII	HAW.	I-H3-1(66)	1992	30	440

SURVEY PLOTTED BY: DATE: 07/6/89
 DRAWN BY: D.E. DRYDEN
 TRACED BY: D.E. DRYDEN
 DESIGNED BY: J.N. QUE
 CHECKED BY: J.N. QUE
 NO.

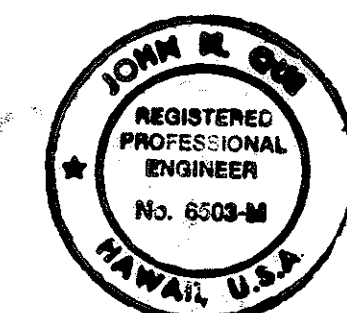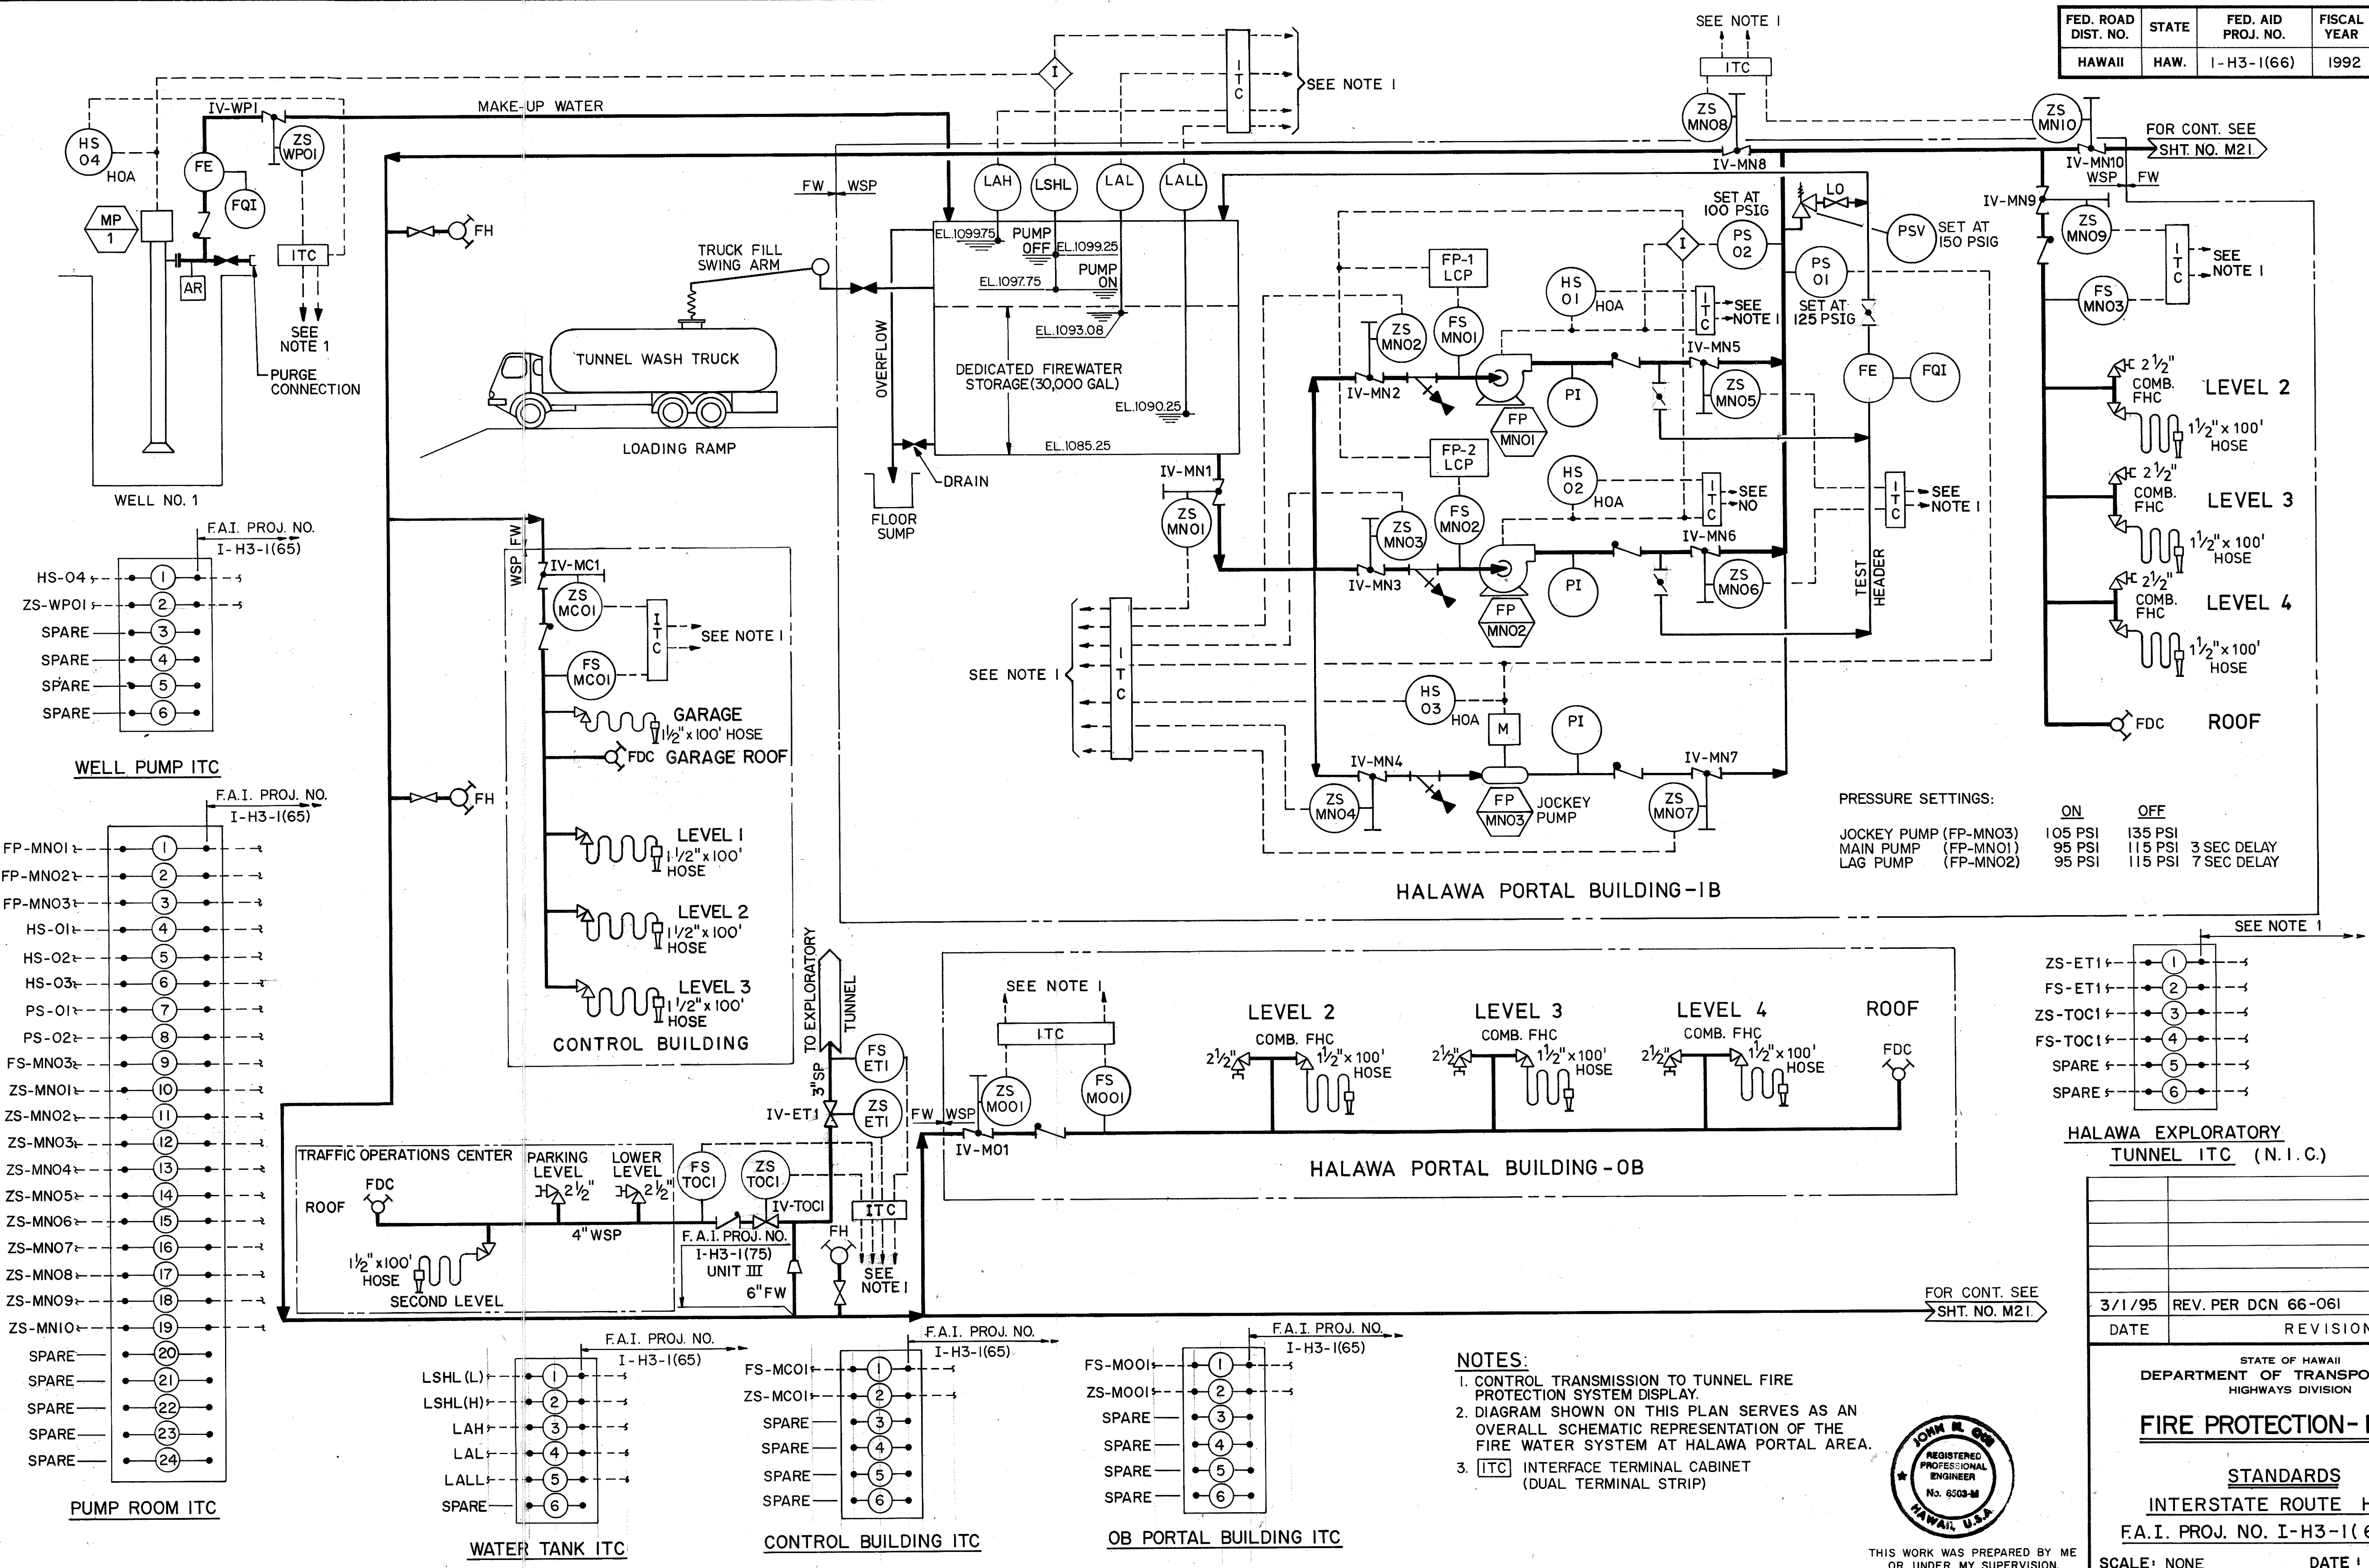


THIS WORK WAS PREPARED BY ME
 OR UNDER MY SUPERVISION.
John R. Que

STATE OF HAWAII DEPARTMENT OF TRANSPORTATION HIGHWAYS DIVISION	
FIRE PROTECTION- P&ID 1	
STANDARDS INTERSTATE ROUTE H-3 F.A.I. PROJ. NO. I-H3-1(66)	
SCALE: NONE	DATE: APR 1992
SHEET NO. M20 OF 28 SHEETS	

FED. ROAD DIST. NO.	STATE	FED. AID PROJ. NO.	FISCAL YEAR	SHEET NO.	TOTAL SHEETS
HAWAII	HAW.	I-H3-1(66)	1992	31	440


SEE NOTE 1.

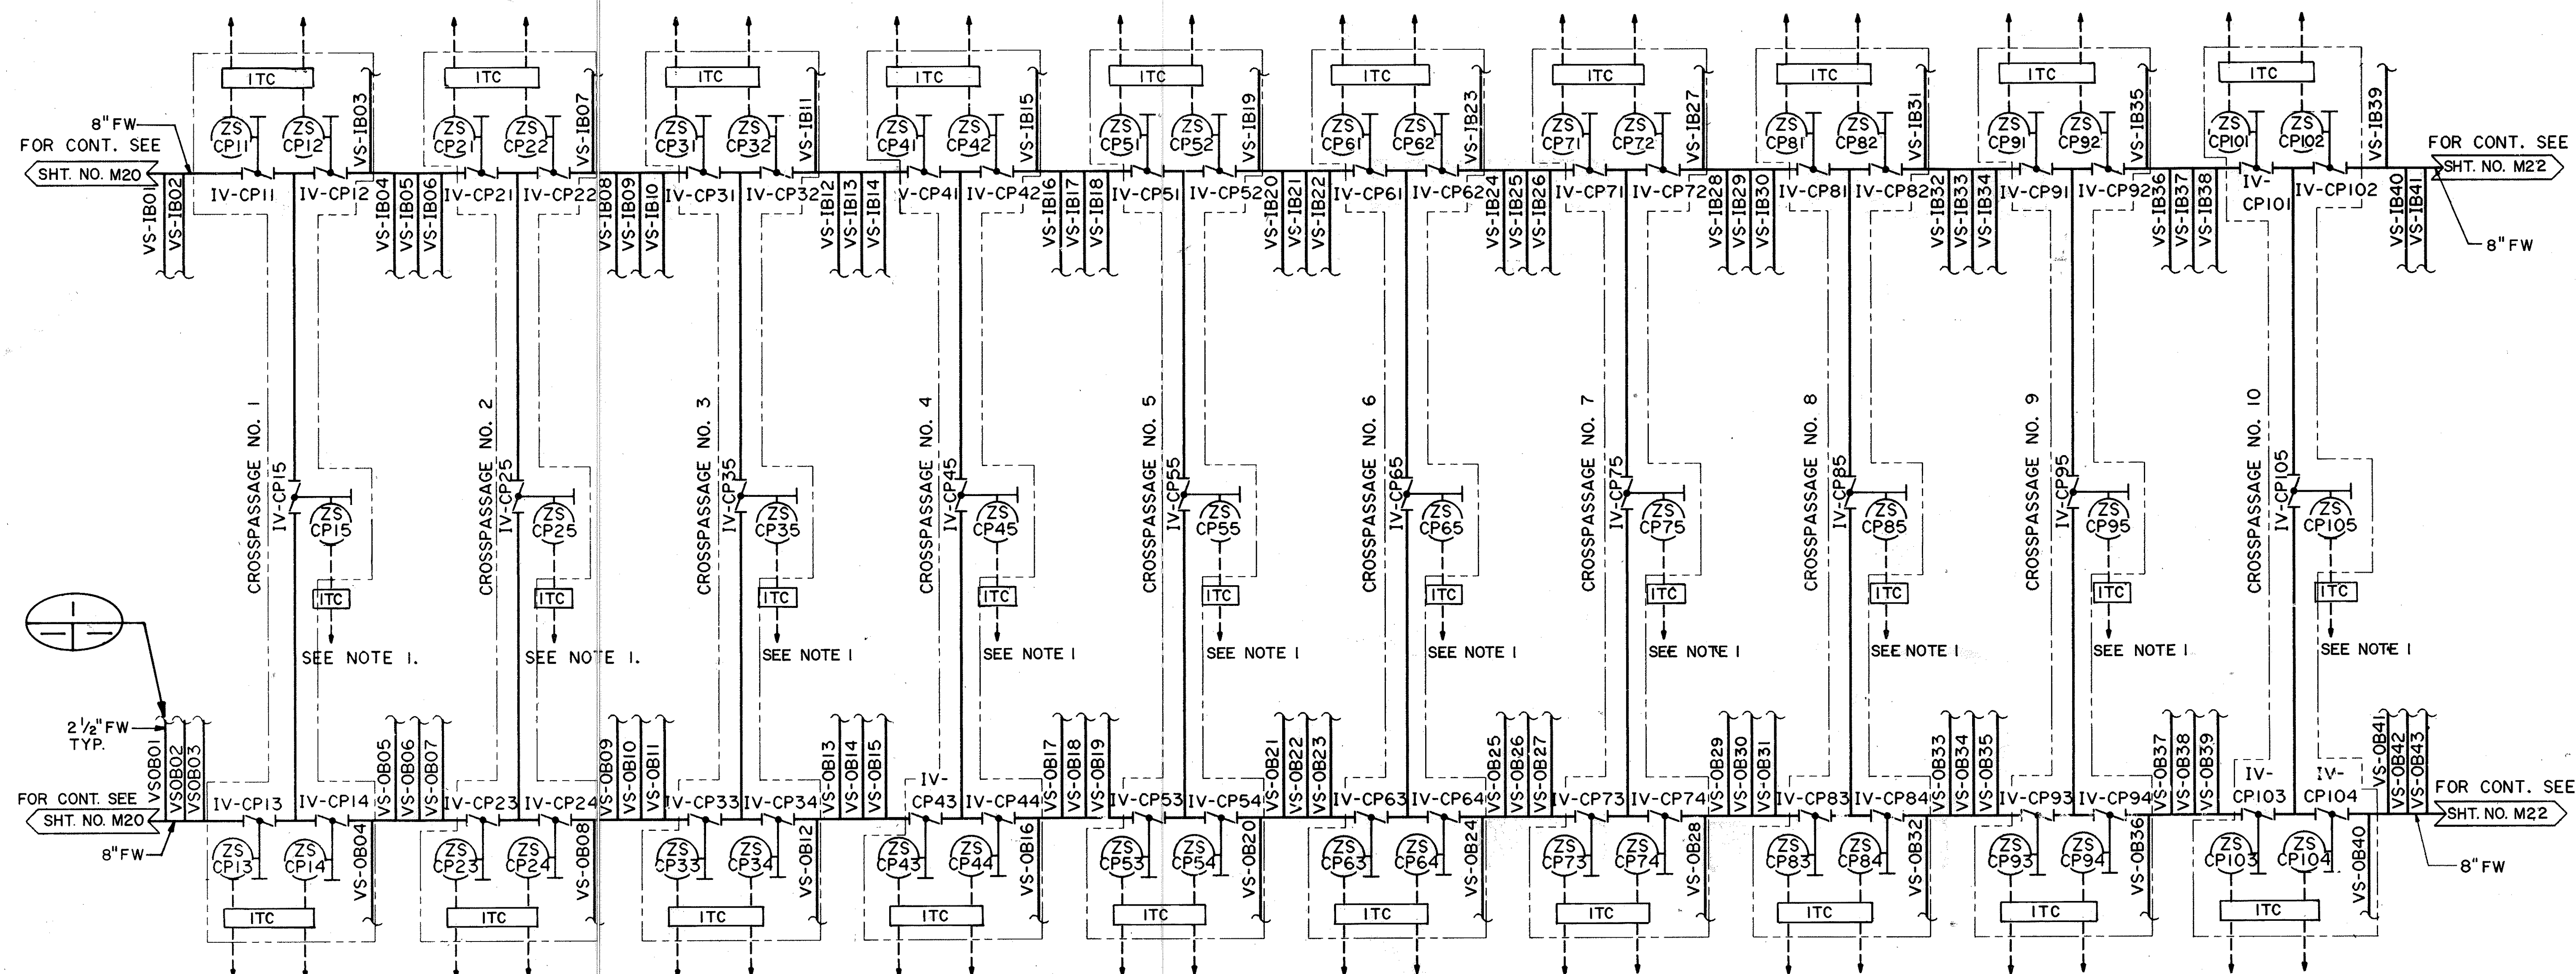


2 1/2" FW TYP.

FOR CONT. SEE SHT. NO. M20


FOR CONT. SEE SHT. NO. M22

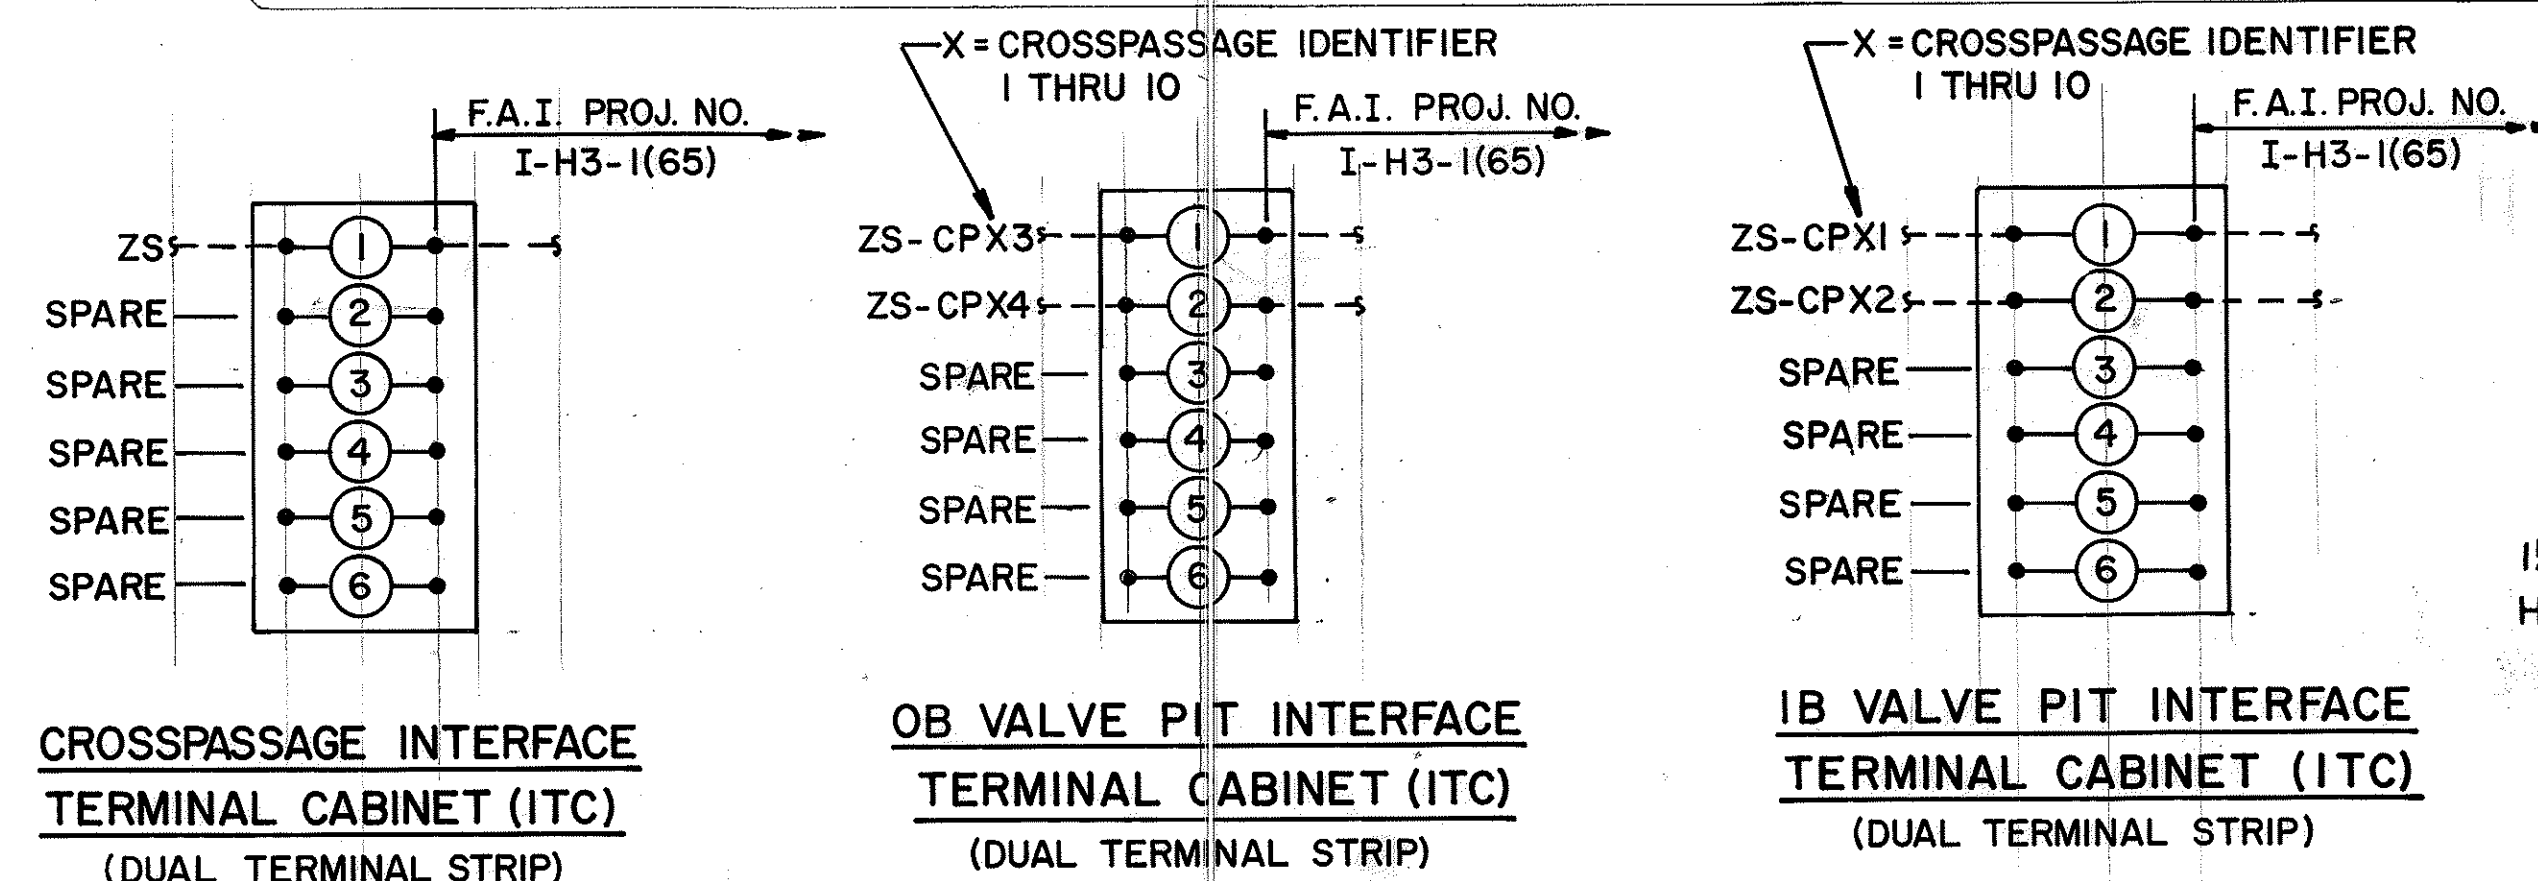

SEE NOTE 1.

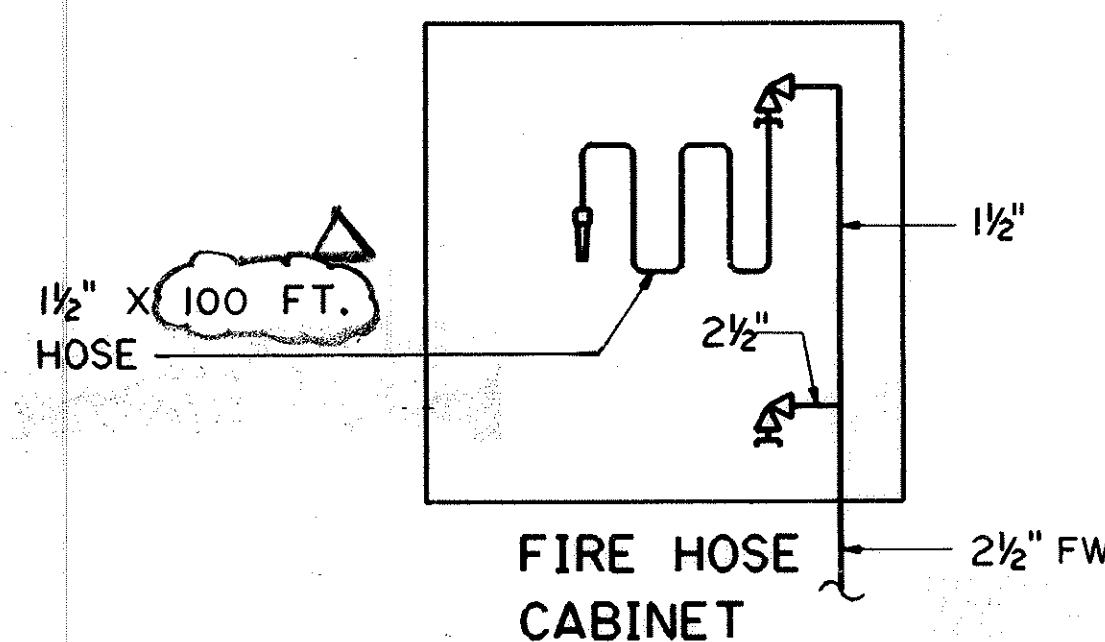


DETAIL
TYP. 85 PLACES

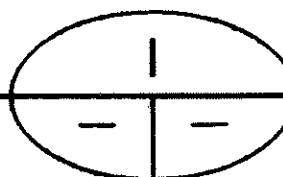

NOTES:


- CONTROL TRANSMISSION TO TUNNEL FIRE PROTECTION SYSTEM DISPLAY.
- DIAGRAM SHOWN ON THIS PLAN SERVES AS AN OVERALL SCHEMATIC REPRESENTATION OF THE FIRE WATER SYSTEM IN THE TUNNELS.

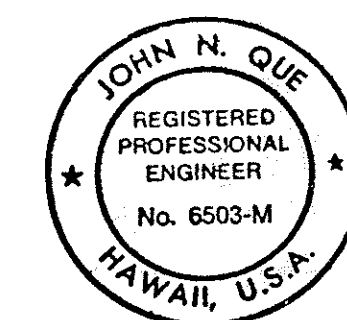


THIS WORK WAS PREPARED BY ME OR UNDER MY SUPERVISION

DATE	REVISION
10/29/93	REVISED LENGTH OF 1 1/2" HOSE FROM 125' TO 100' PER DCN 66-024
DATE	REVISION
STATE OF HAWAII DEPARTMENT OF TRANSPORTATION HIGHWAYS DIVISION	
FIRE PROTECTION -	
P & ID - 2	
STANDARDS	
INTERSTATE ROUTE H-3	
F.A.I. PROJ. NO. I-H3-1(66)	
SCALE: NONE	DATE: APR 1992
SHEET NO. M2.1 OF 28 SHEETS	

FED. ROAD DIST. NO.	STATE	FED. AID PROJ. NO.	FISCAL YEAR	SHEET NO.	TOTAL SHEETS
HAWAII	HAW.	I-H3-1(66)	1992	32	440

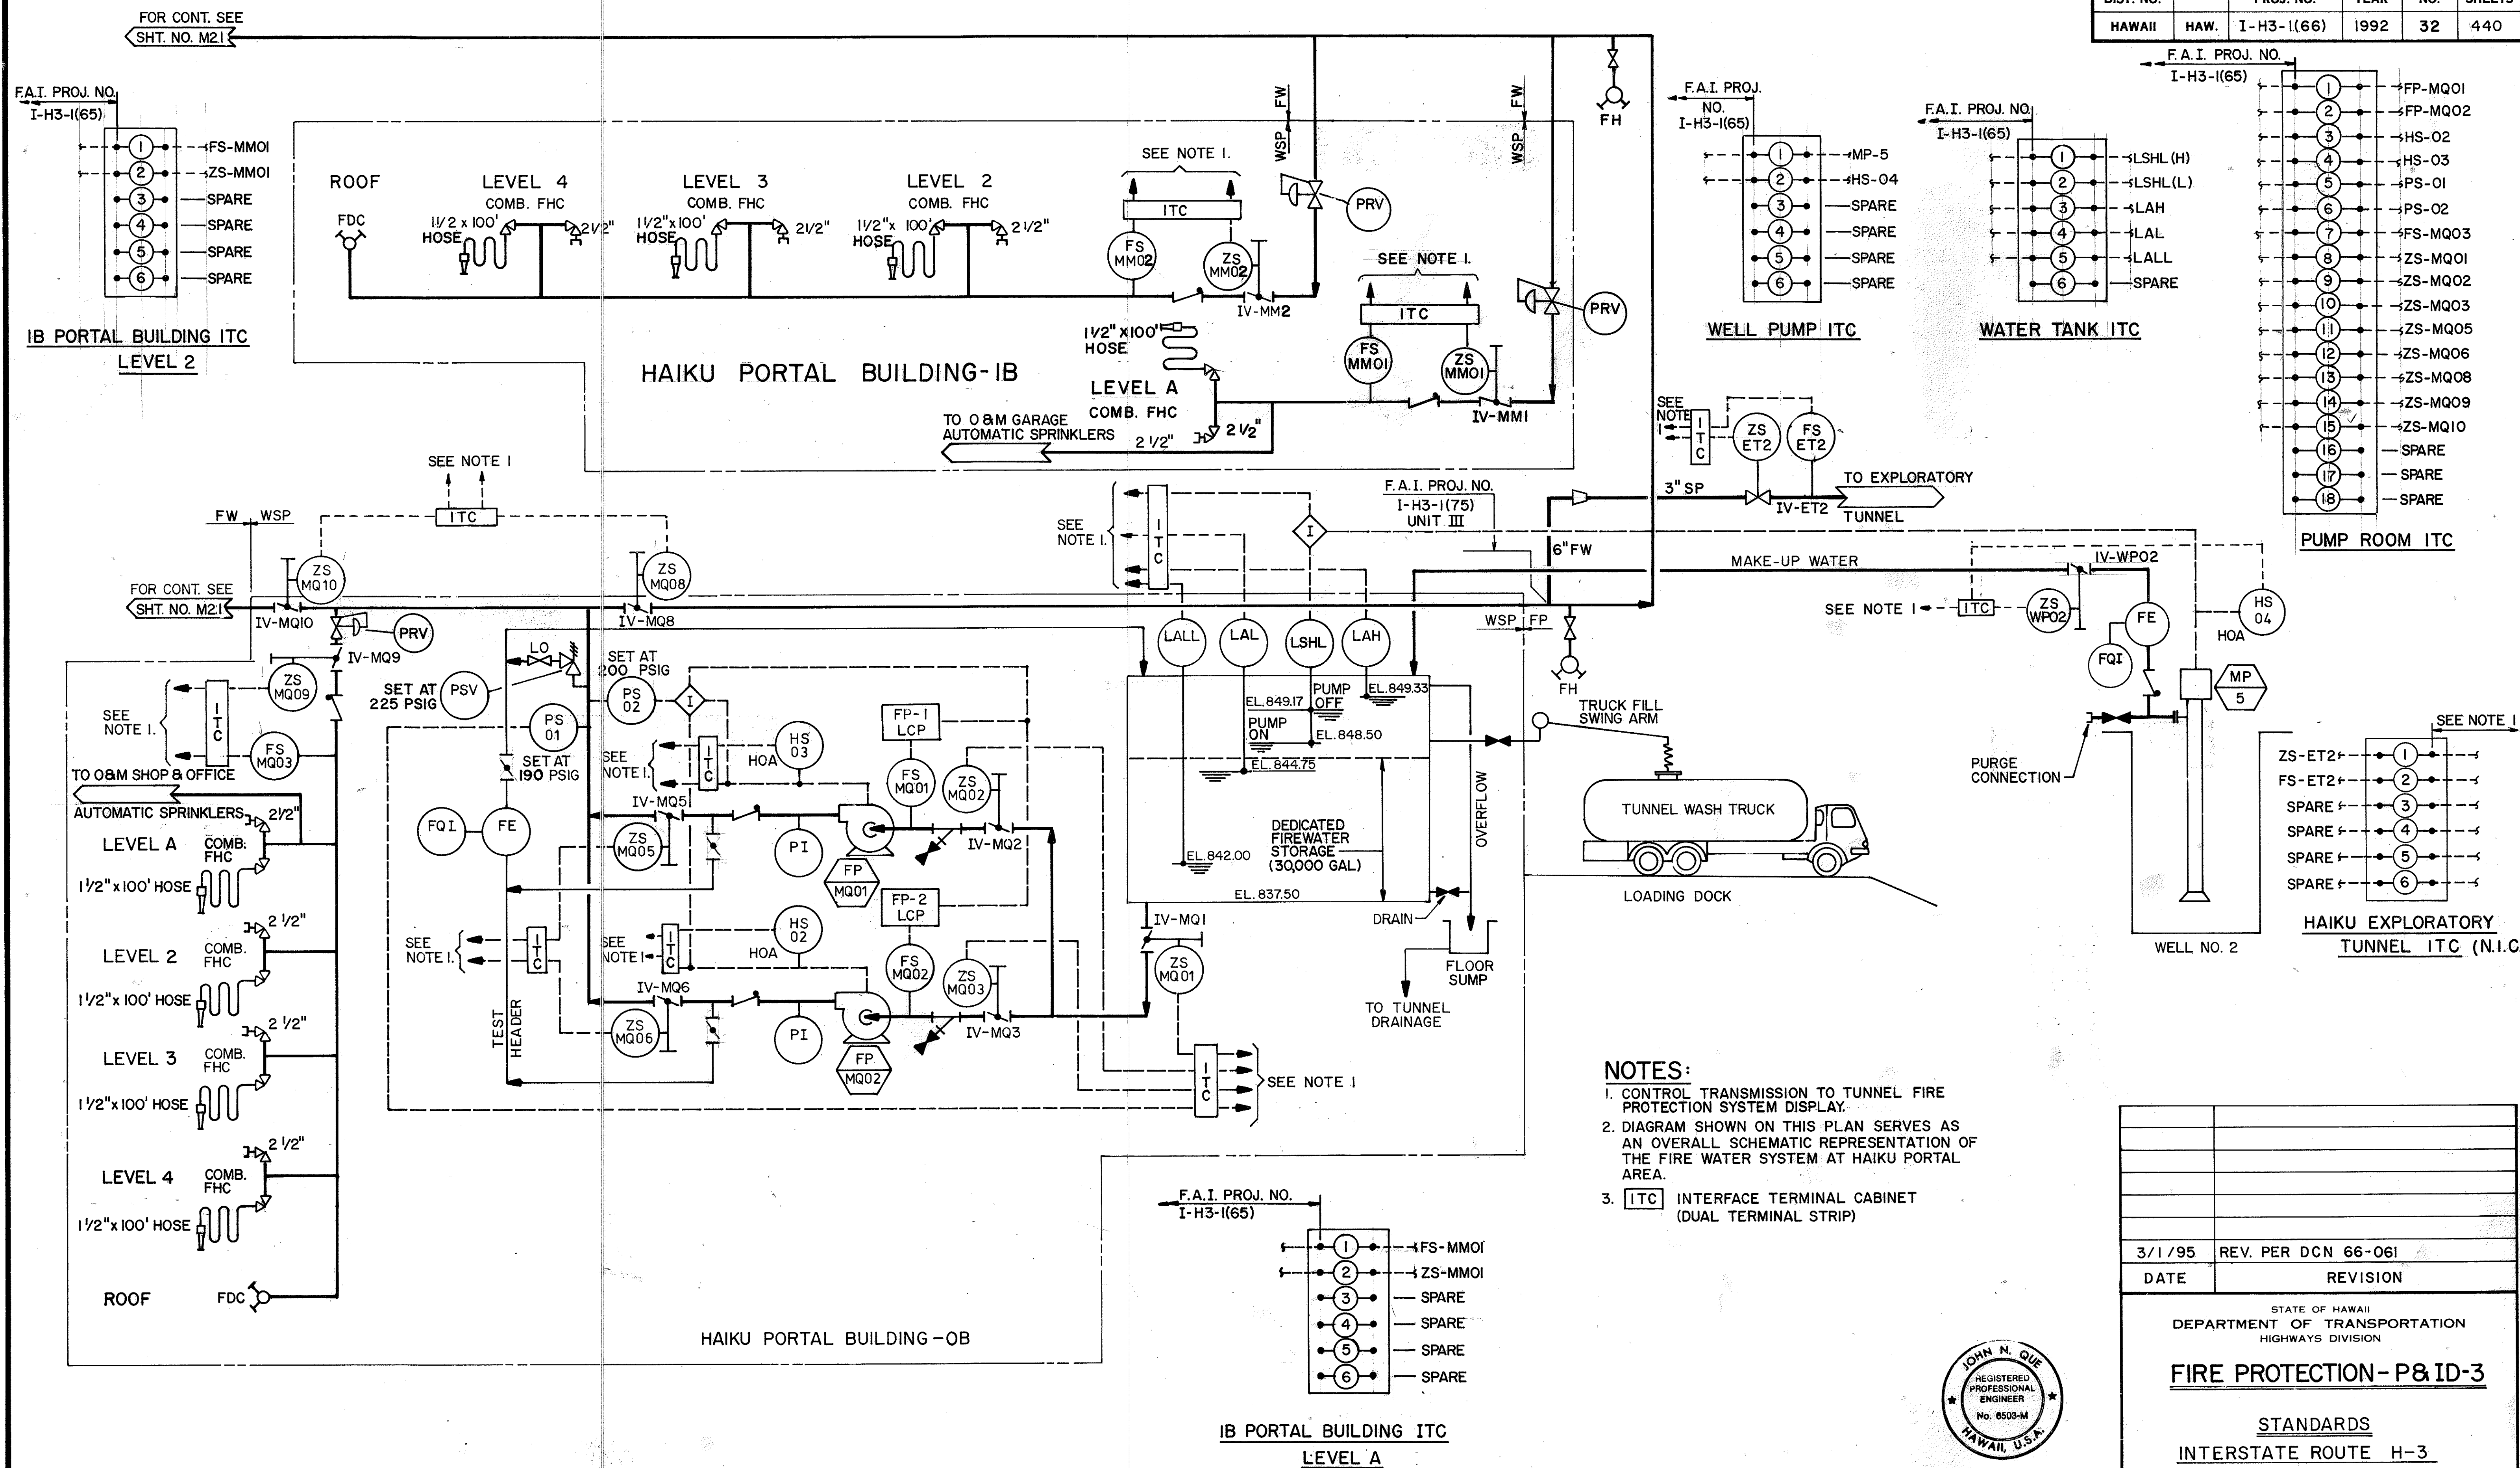


FED. ROAD DIST. NO.	STATE	FED. AID PROJ. NO.	FISCAL YEAR	SHEET NO.	TOTAL SHEETS
HAWAII	HAW.	I-H3-1(66)	1992	33	440

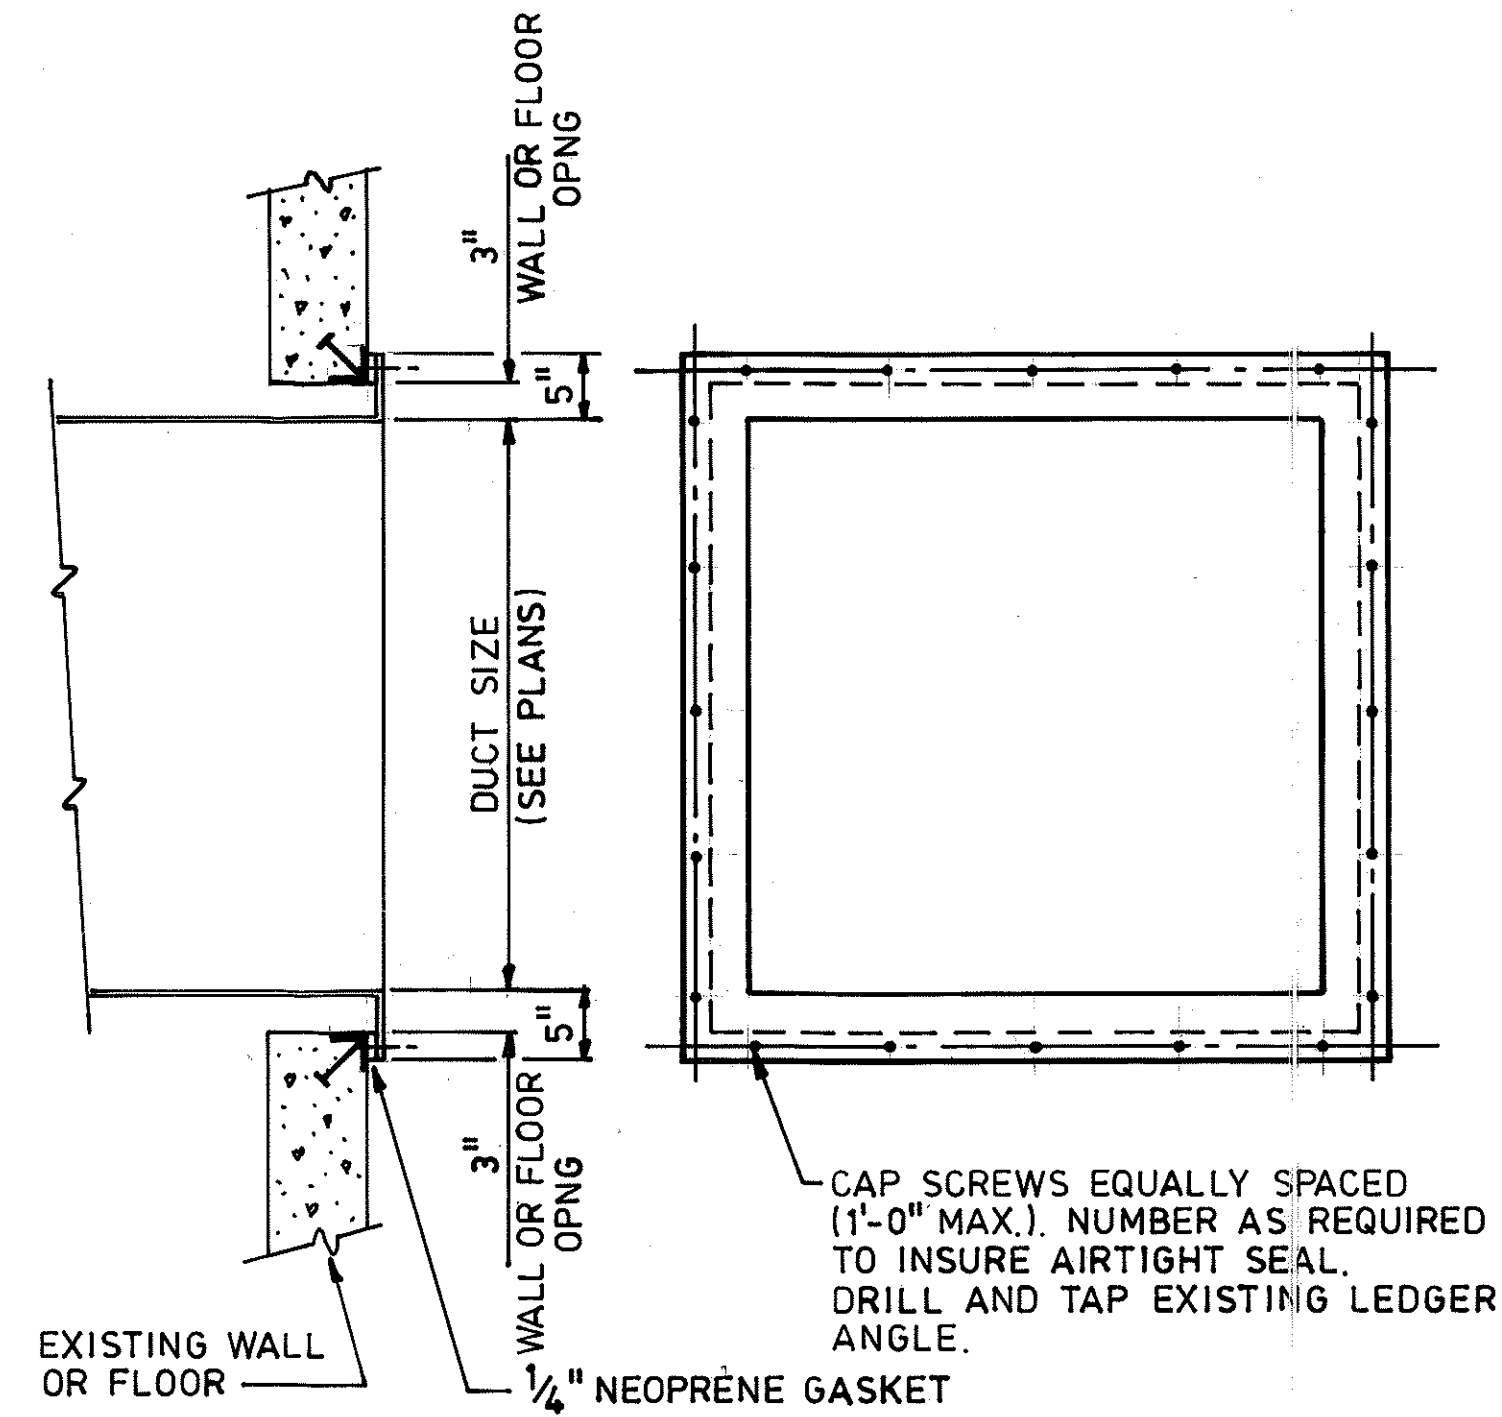


TYPICAL DUCT TO INTERIOR WALL OR FLOOR PENETRATION ATTACHMENT

DETAIL 1

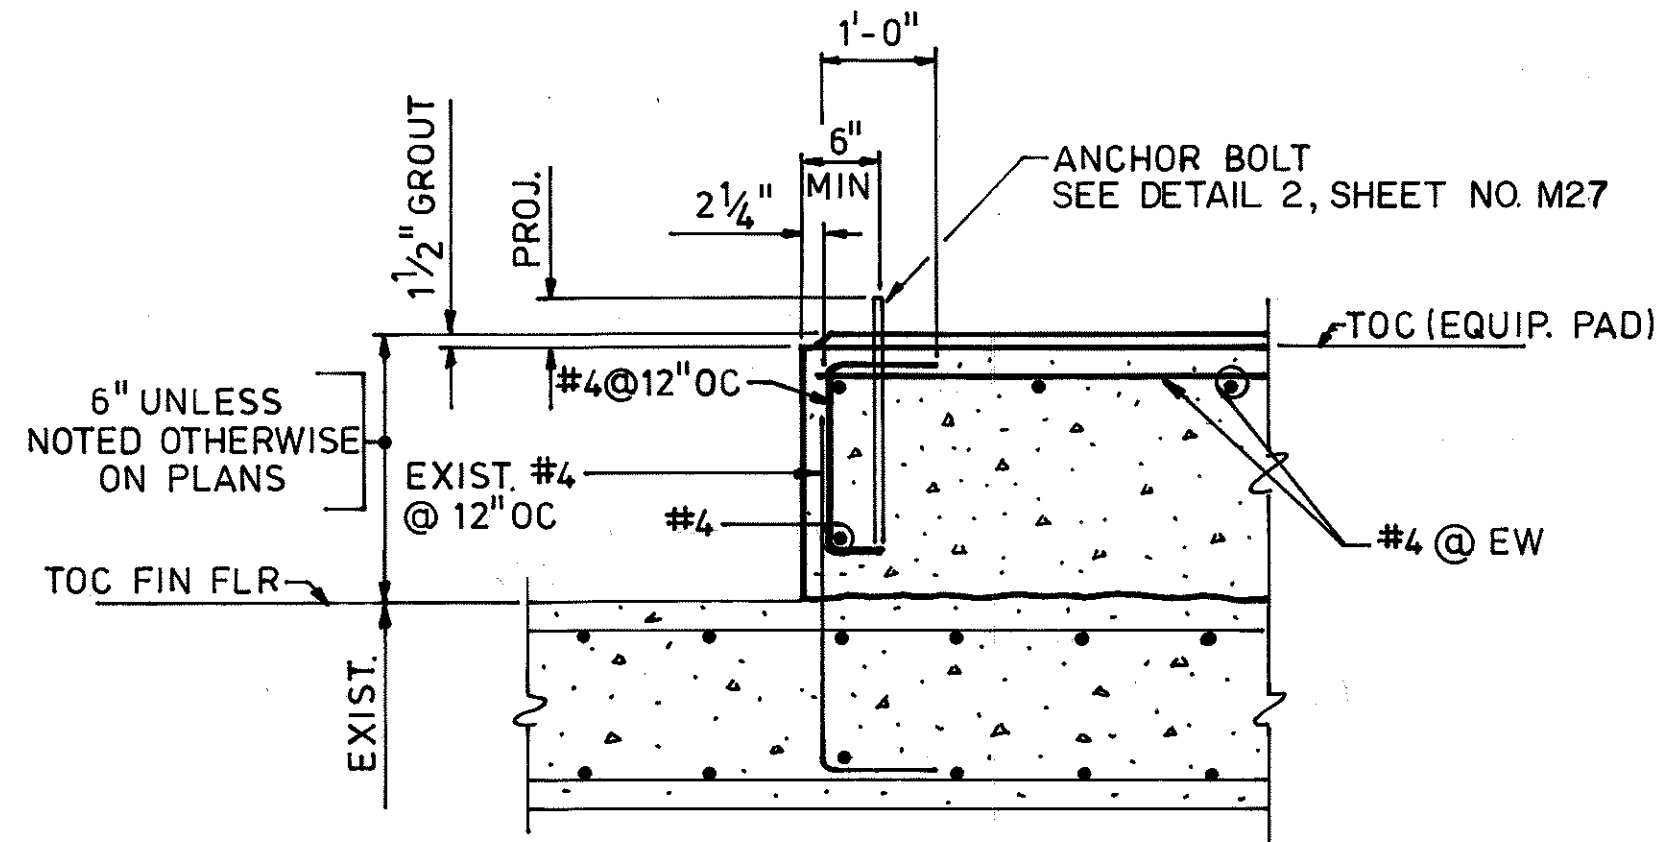


TYPICAL EQUIPMENT PAD

DETAIL 2

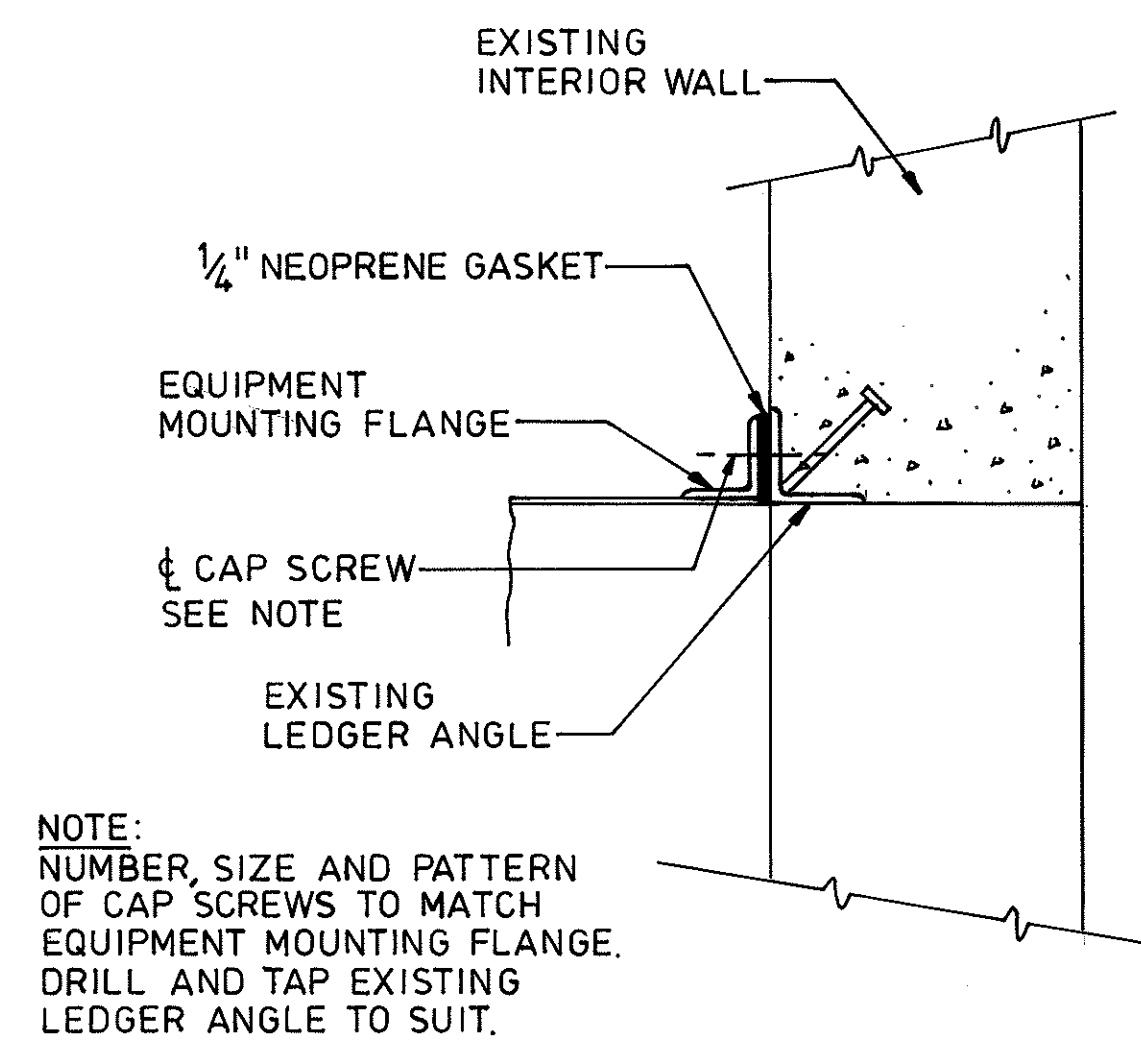

TYPICAL EQUIPMENT TO INTERIOR WALL MOUNTING DETAIL


DETAIL 3

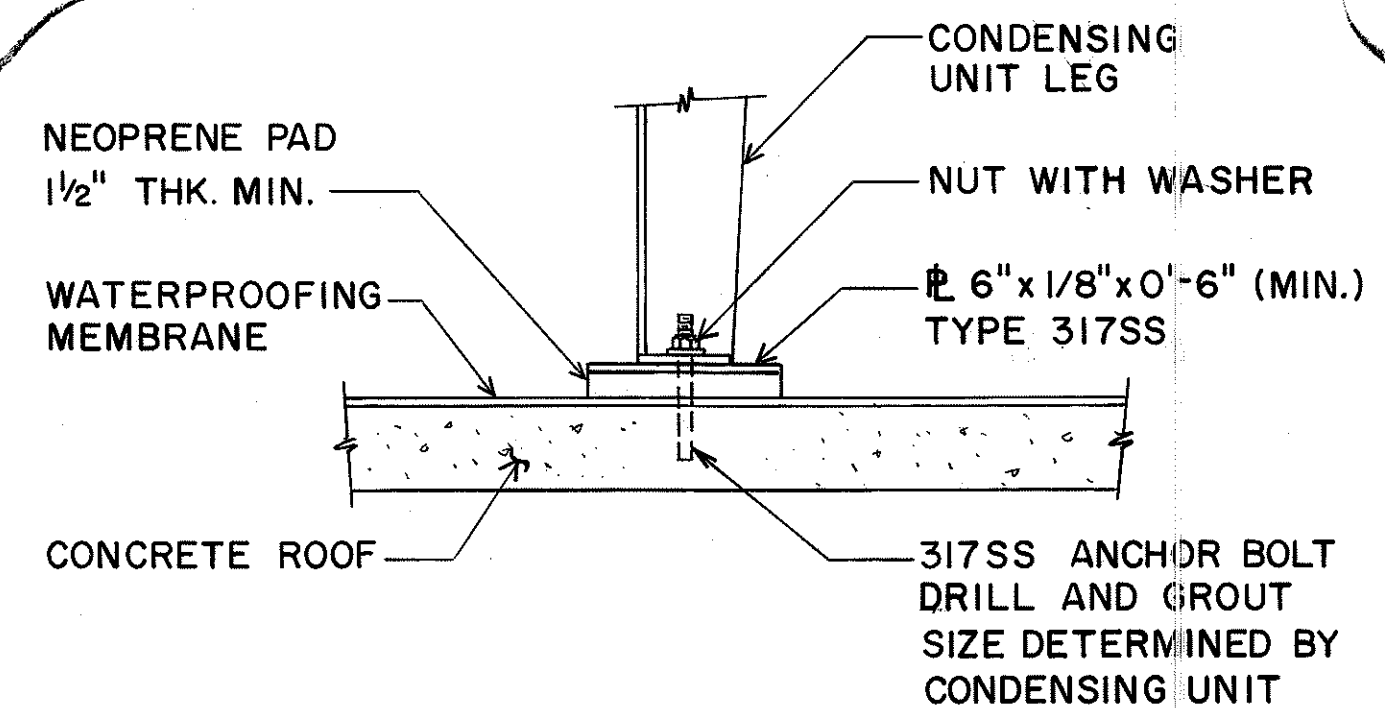

- NOTES:
1. APPLY SILICONE SEALANT LIBRARY BETWEEN PAD AND MEMBRANE BEFORE SETTING CONDENSING UNIT.
 2. SHIM AS REQUIRED, IN ADDITION TO THE 1/8" PLATE SHOWN, TO LEVEL UNIT

ROOF-MOUNTED CONDENSING UNIT INSTALLATION

DETAIL 4

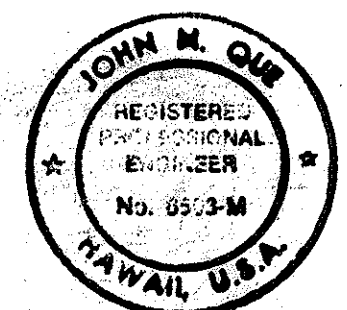

THIS WORK WAS PREPARED BY ME OR UNDER MY SUPERVISION

9/23/93	ADDED DETAIL PER DCN. 66-018
DATE	REVISION

STATE OF HAWAII
DEPARTMENT OF TRANSPORTATION
HIGHWAYS DIVISION

HVAC-DETAILS-1


STANDARDS
INTERSTATE ROUTE H-3
F.A.I. PROJ. NO. I-H3-1(66)

SCALE: NONE DATE: APR 1992

SHEET NO. M23 OF 28 SHEETS



ORIGINAL PLAN	DATE
9/25/89	9/25/89
DESIGNED BY	9/22/89
9/22/89	9/22/89
CHECKED BY	05/01/90
05/01/90	05/01/90

FED. ROAD DIST. NO.	STATE	FED. AID PROJ. NO.	FISCAL YEAR	SHEET NO.	TOTAL SHEETS
HAWAII	HAW.	I - H3 - 1(66)	1992	34	440

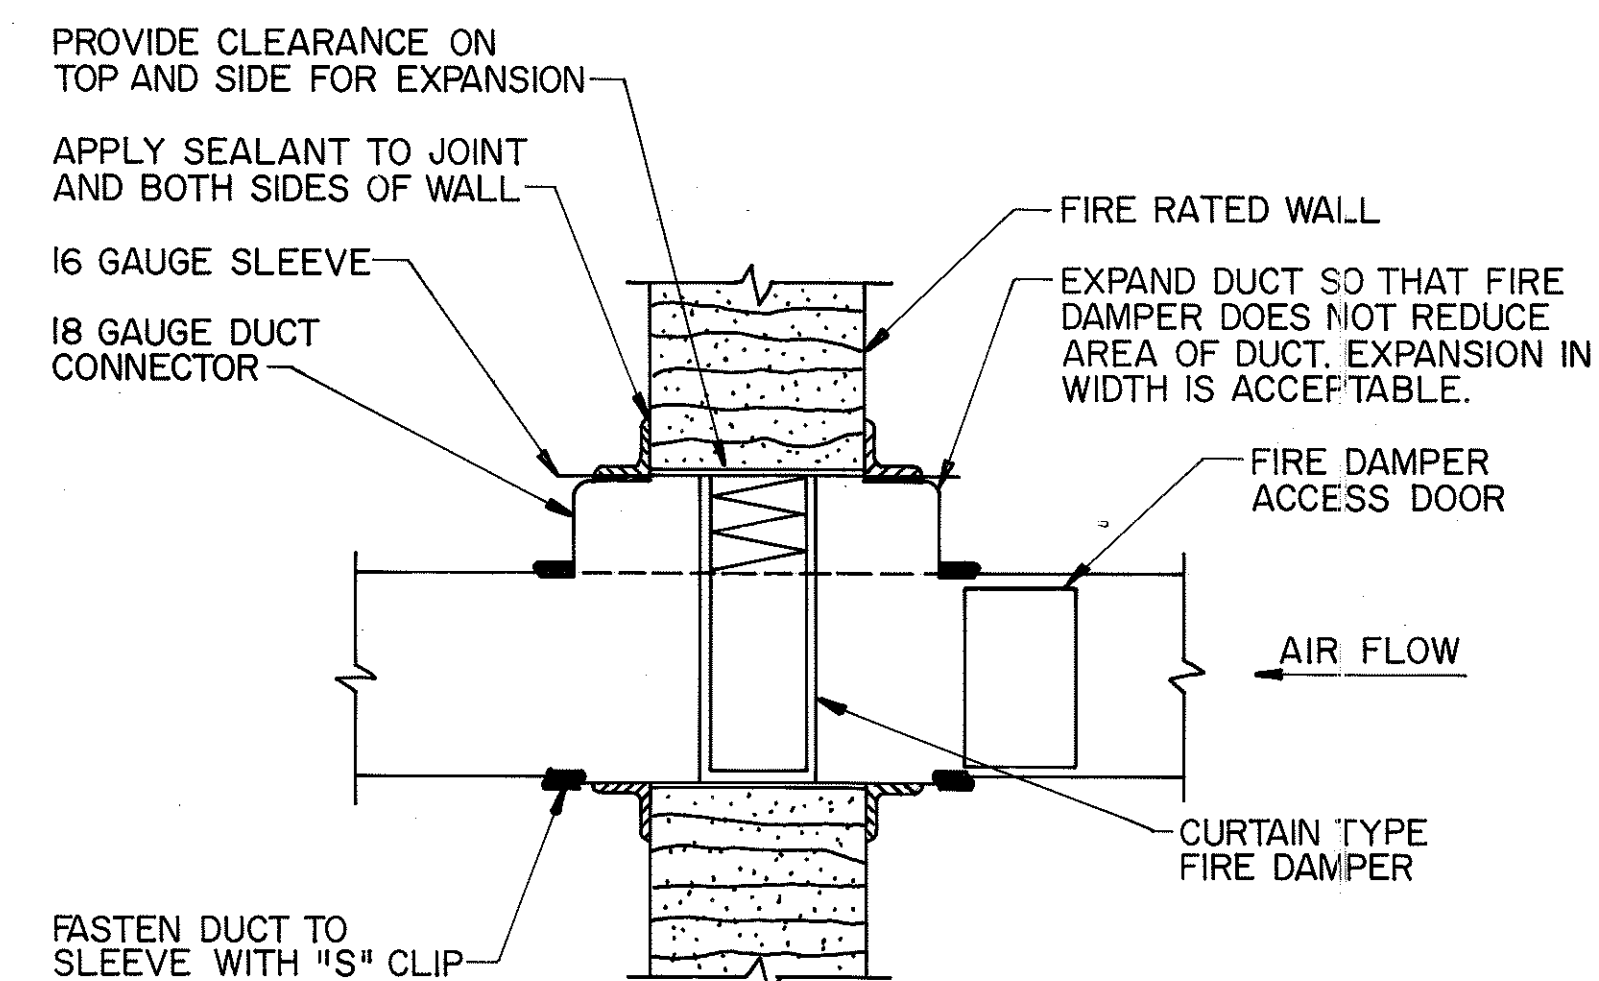



FIRE DAMPER IN DUCT
AT FIRE RATED WALL

DETAIL

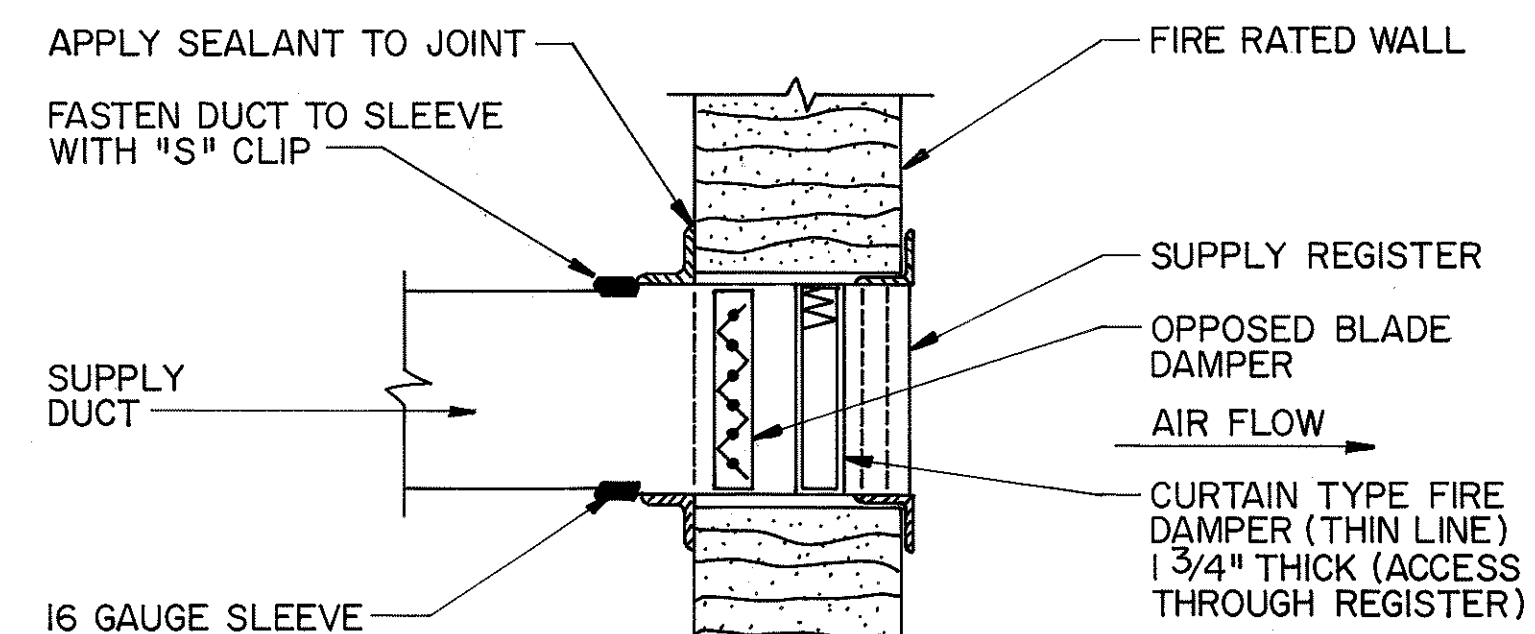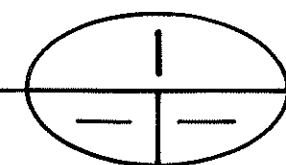



FIRE DAMPER AND SUPPLY REGISTER AT FIRE RATED WALL

DETAIL

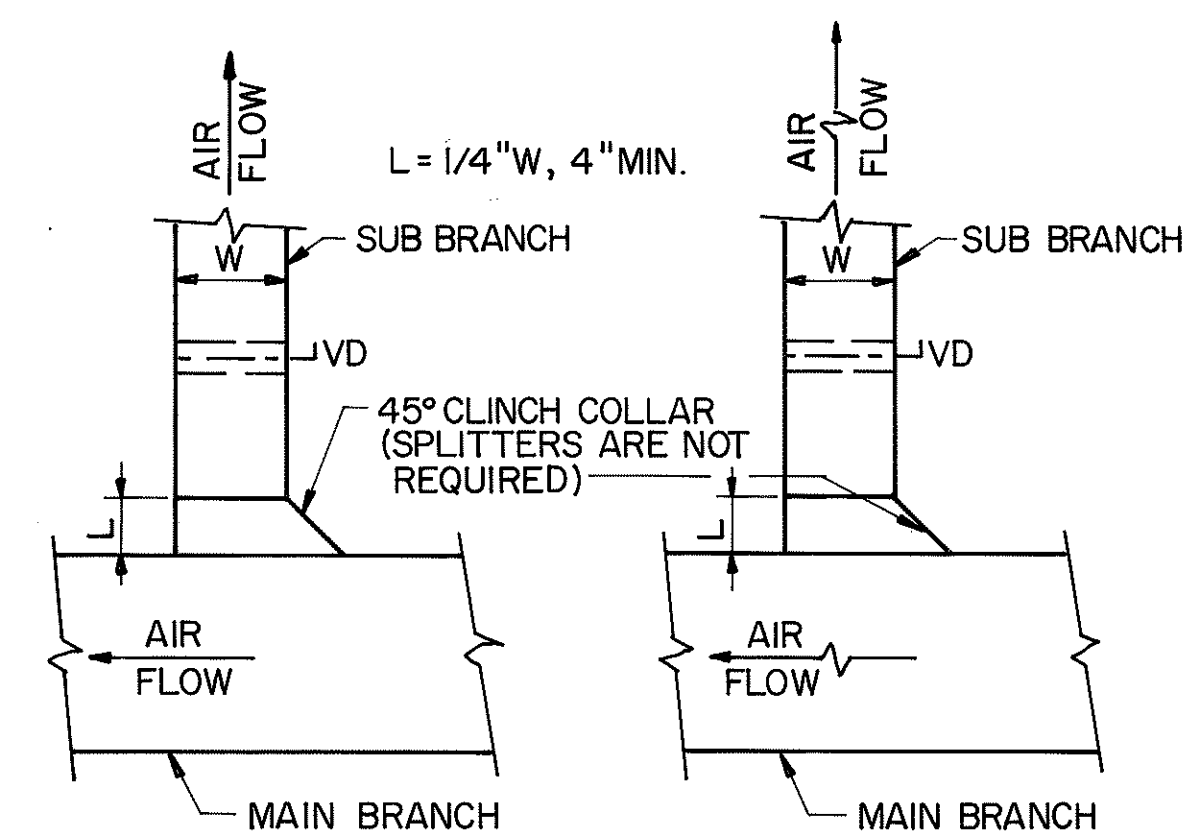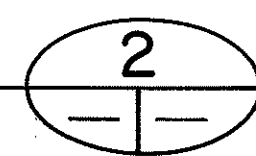



SUPPLY, RETURN AND
EXHAUST DUCT BRANCH

DETAIL

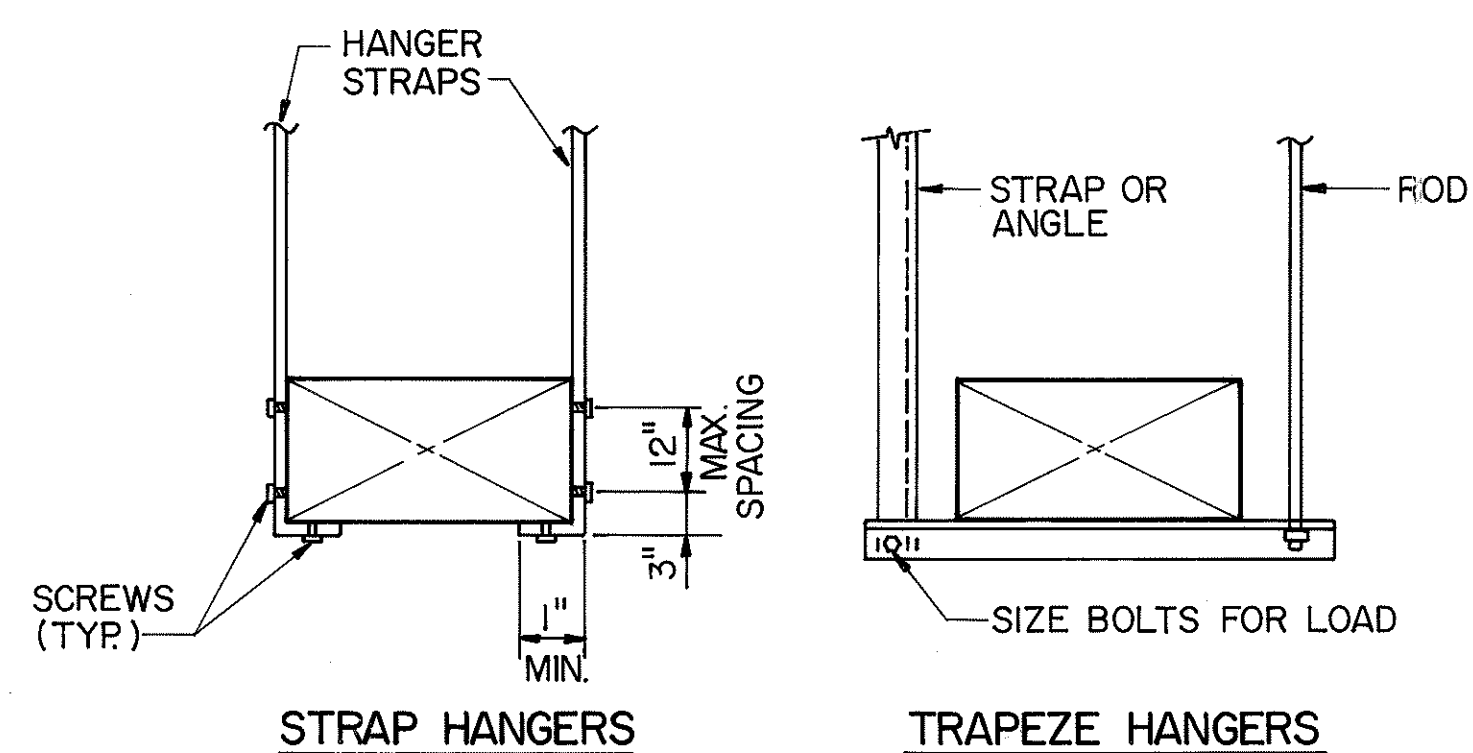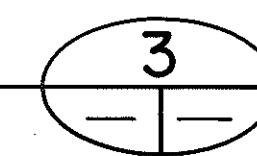



HANGER ATTACHMENTS FOR RECTANGULAR DUCTS

DETAIL

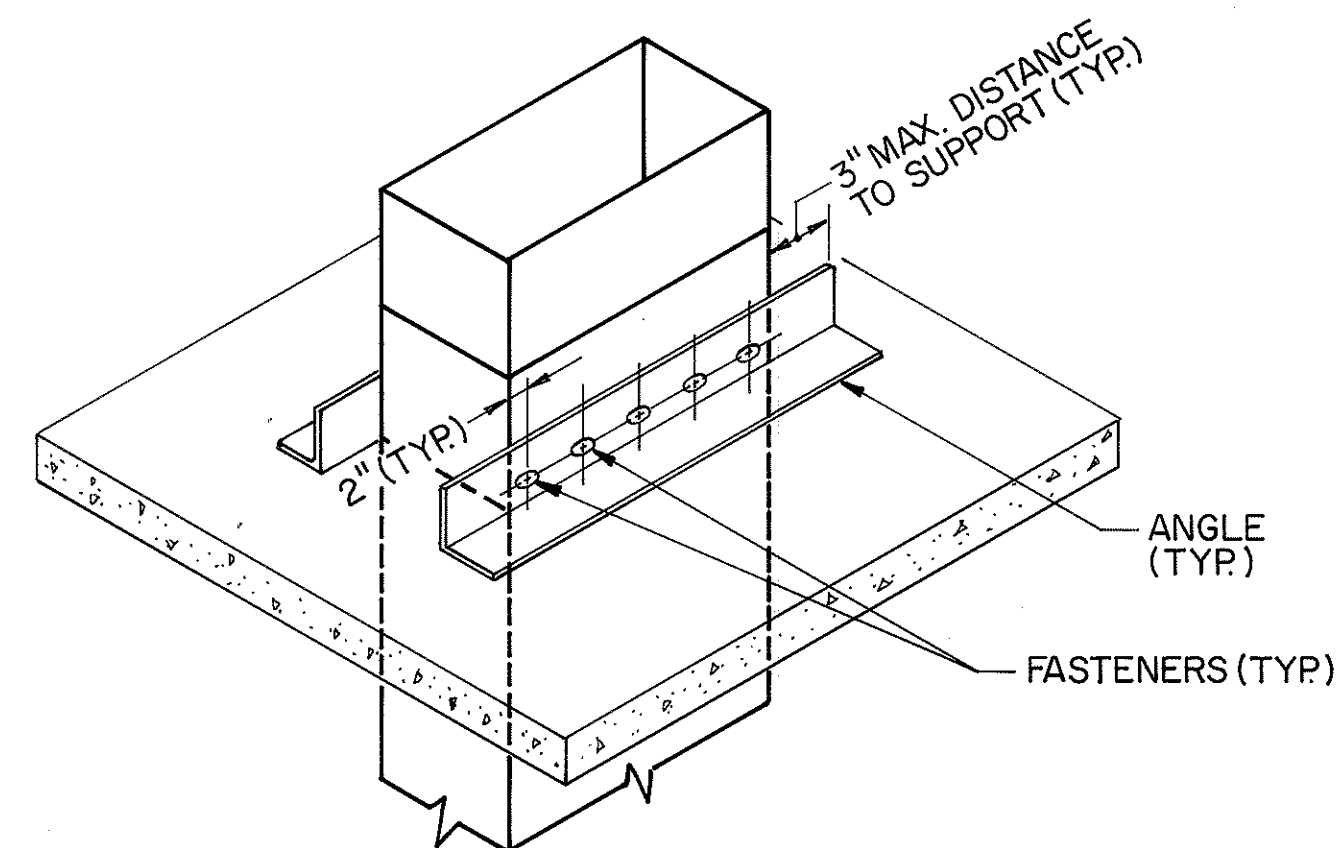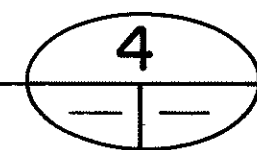



RISER SUPPORTS FROM FLOOR

DETAIL

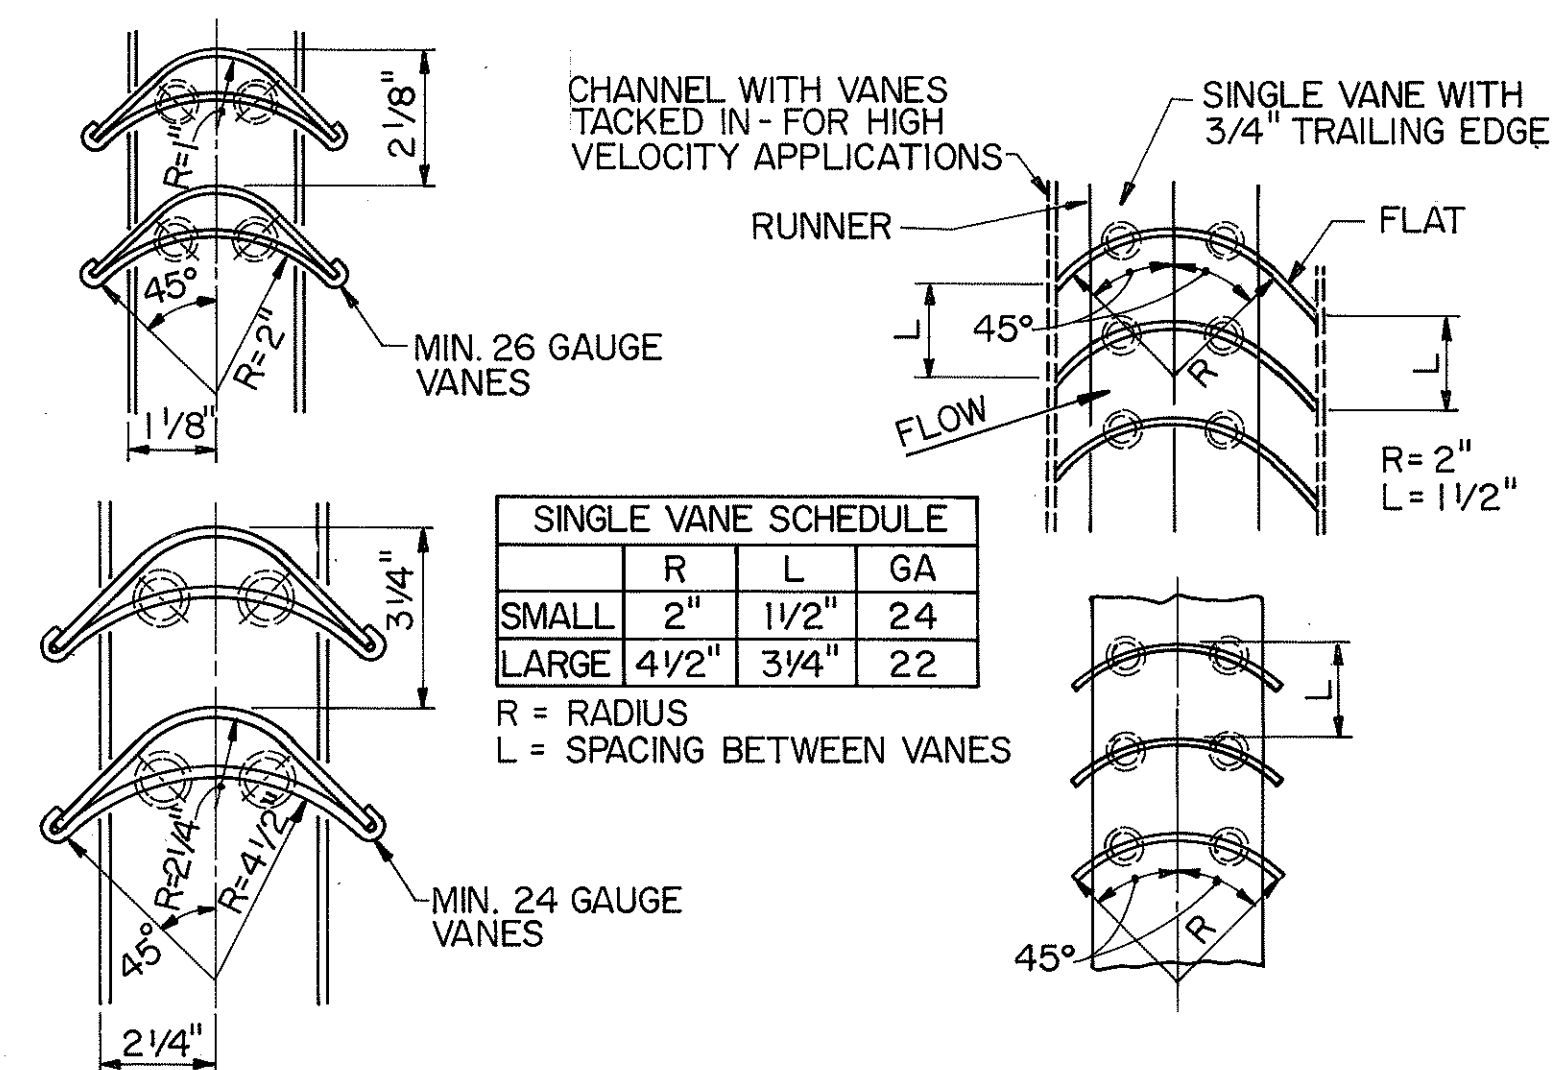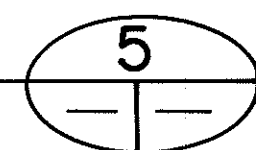

TURNING VANES

DETAIL

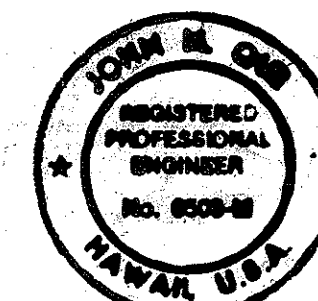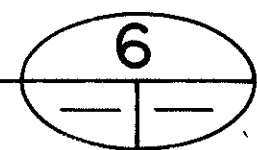

THIS WORK WAS PREPARED BY ME
OR UNDER MY SUPERVISION

John Doe

DATE	REVISION

STATE OF HAWAII
DEPARTMENT OF TRANSPORTATION
HIGHWAYS DIVISION

HVAC - DETAILS 2

STANDARDS


INTERSTATE ROUTE H-3

F.A.I. PROJ. NO. I-H3-1 (66)

SCALE: NONE
DATE: APR 1992


SHEET NO. M24
OF 28 SHEETS

FED. ROAD DIST. NO.	STATE	FED. AID PROJ. NO.	FISCAL YEAR	SHEET NO.	TOTAL SHEETS
HAWAII	HAW.	I-H3-1(66)	1992	35	440

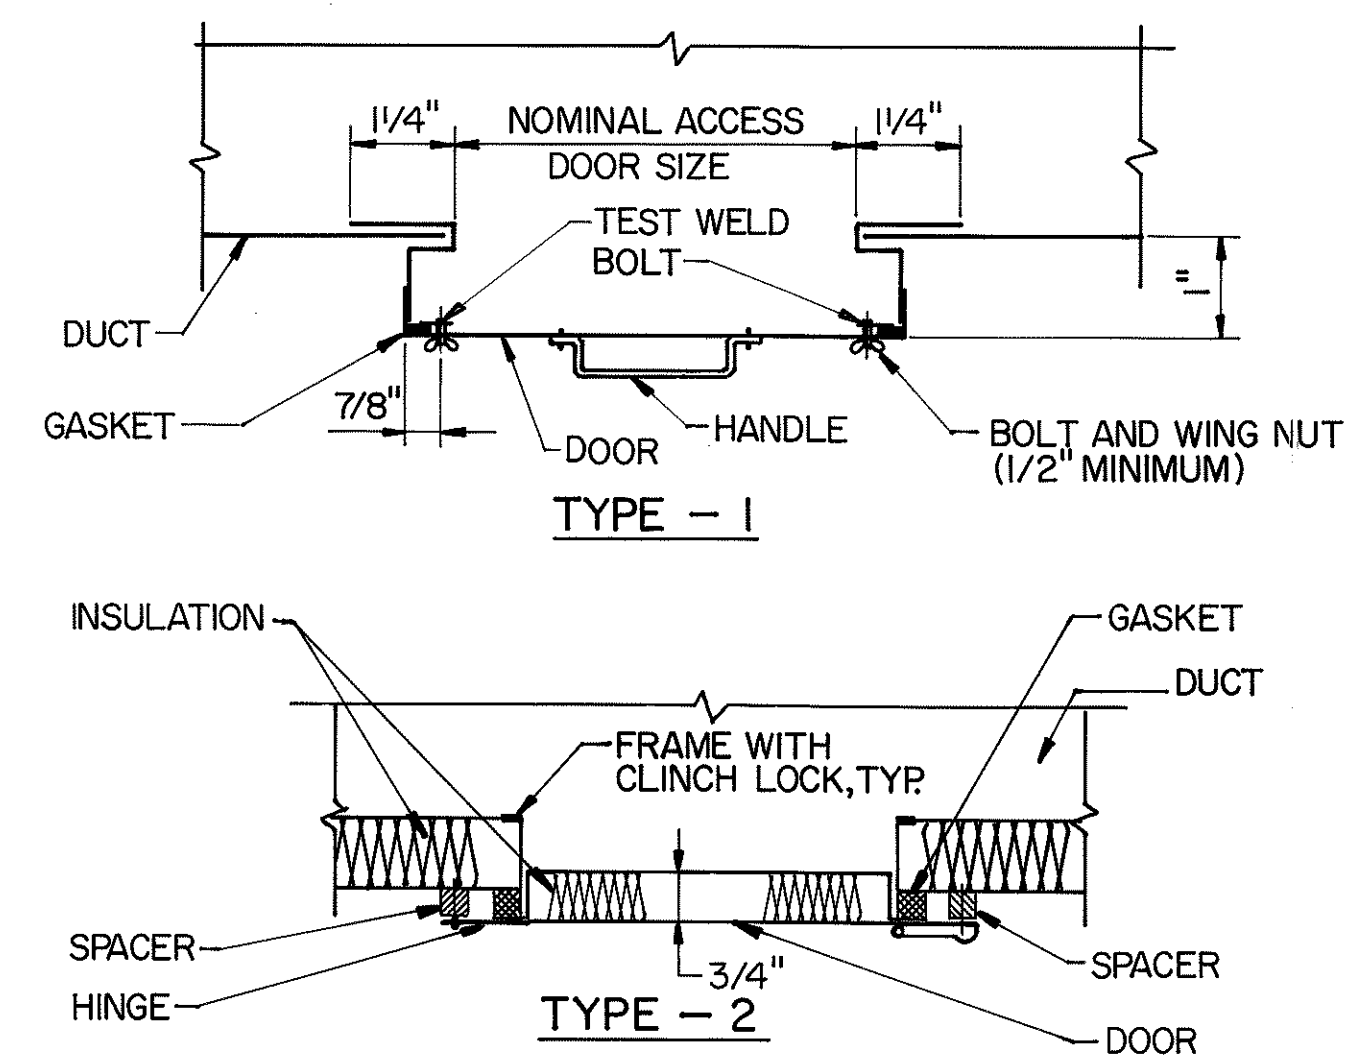

DUCT ACCESS DOORS

DETAIL

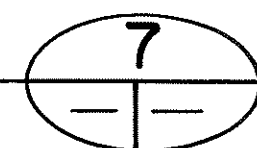[illegible]

STATE OF HAWAII
DEPARTMENT OF TRANSPORTATION
HIGHWAYS DIVISION


HVAC - DETAILS 3

STANDARDS

INTERSTATE ROUTE H-3

F.A.I. PROJ. NO. I-H3-1(66)

SCALE: NONE DATE: APR. 1992
SHEET NO. M25 OF 28 SHEETS

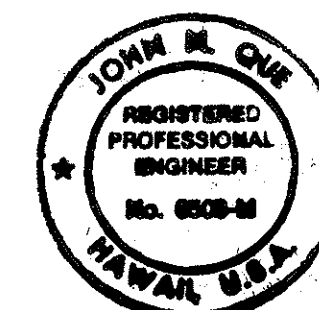


THIS WORK WAS PREPARED BY ME
OR UNDER MY SUPERVISION

John Doe


(ORIGINAL PLAN	SURVEY PLOTTED BY	DATE
	DRAWN BY <u>B. BUNYI</u>	<u>04/16/89</u>
	TRACED BY _____	" "
NOTE BOOK	DESIGNED BY <u>A. H. PORTIER</u>	<u>04/11/89</u>
	QUANTITIES BY _____	" "
No. _____	CHECKED BY <u>J. N. QUE</u>	<u>06/07/90</u>

FED. ROAD DIST. NO.	STATE	FED. AID PROJ. NO.	FISCAL YEAR	SHEET NO.	TOTAL SHEETS
HAWAII	HAW.	I - H3 - I(66)	1992	36	440

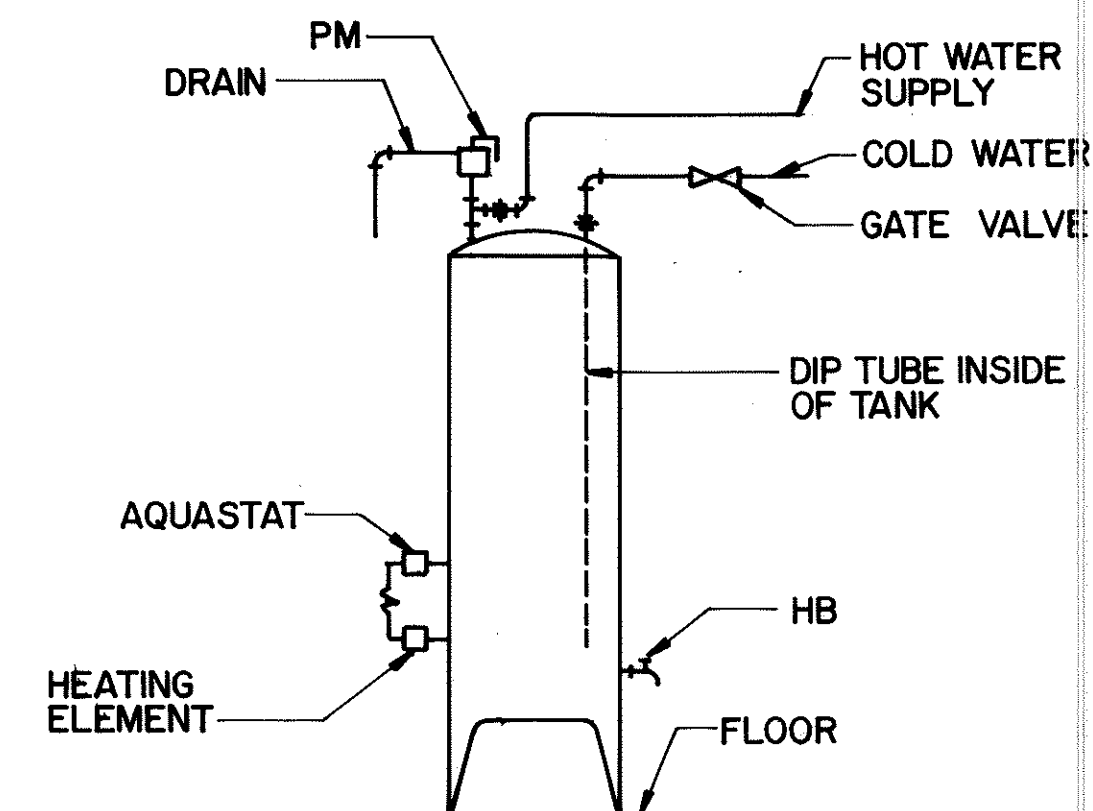


ELECTRIC WATER HEATER WH-1

DETAIL 

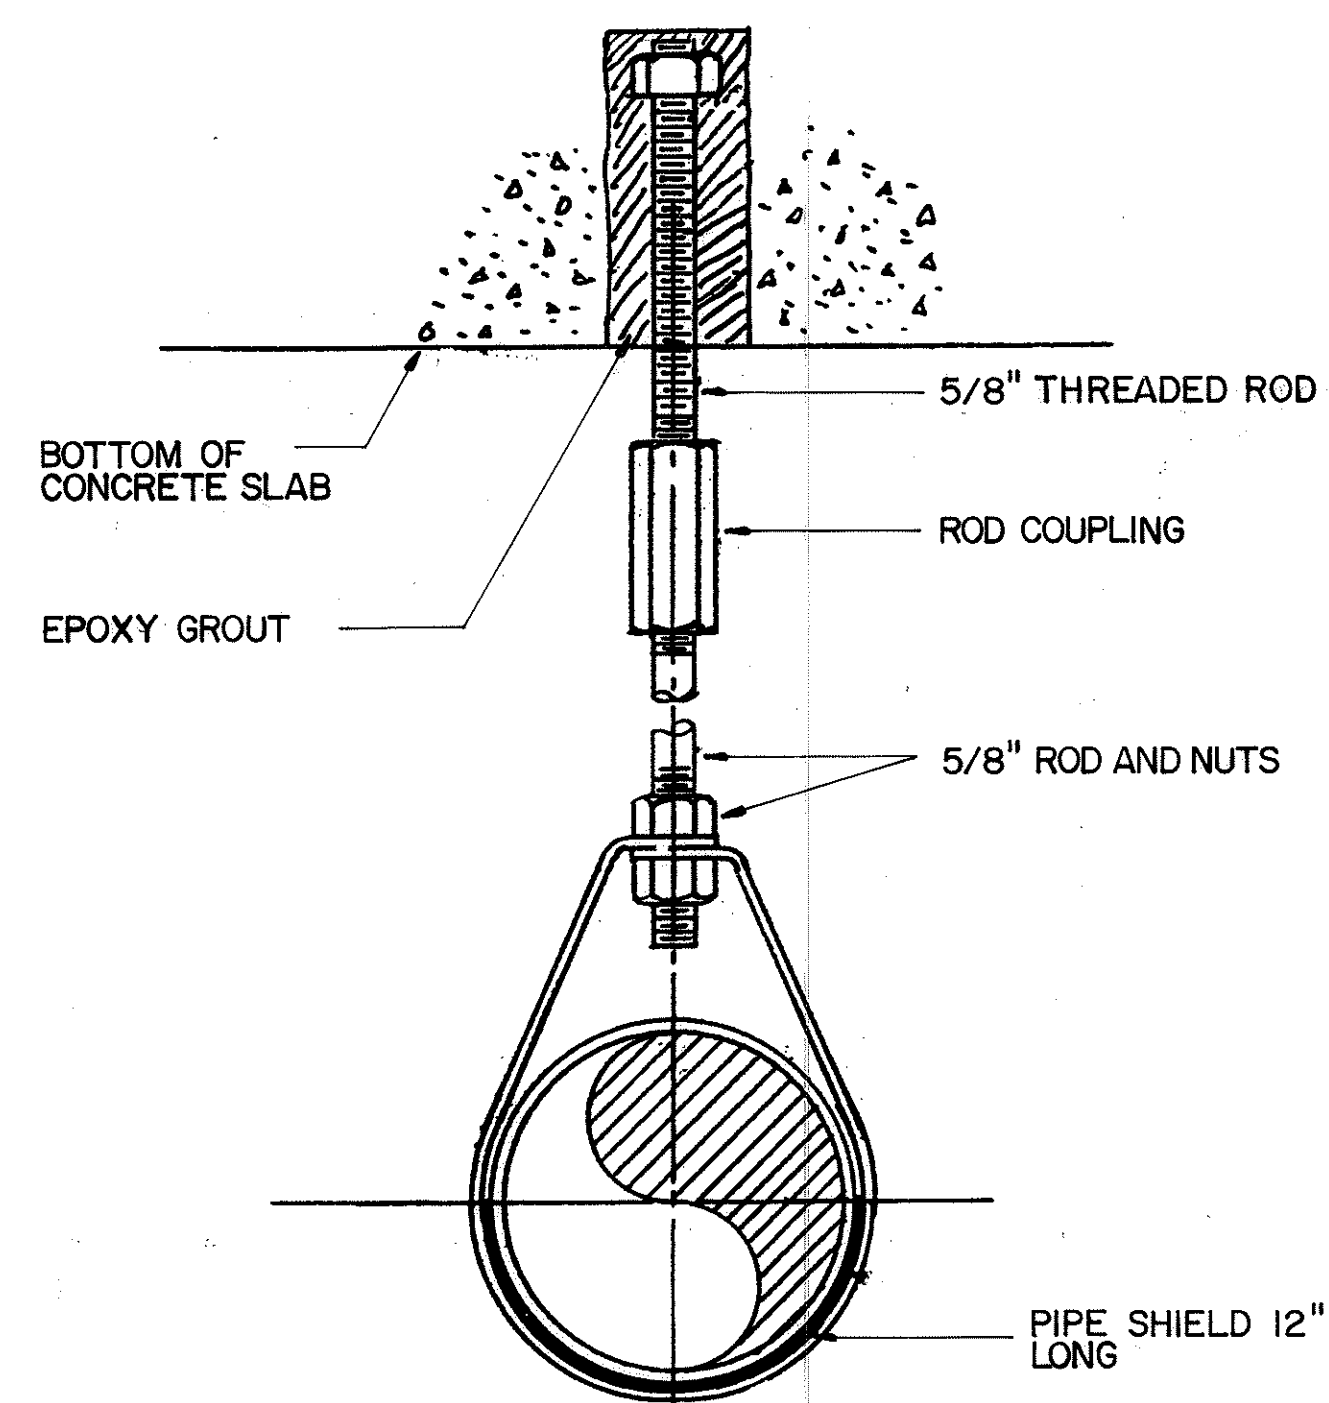


PIPE SUPPORT

DETAIL 2 M26

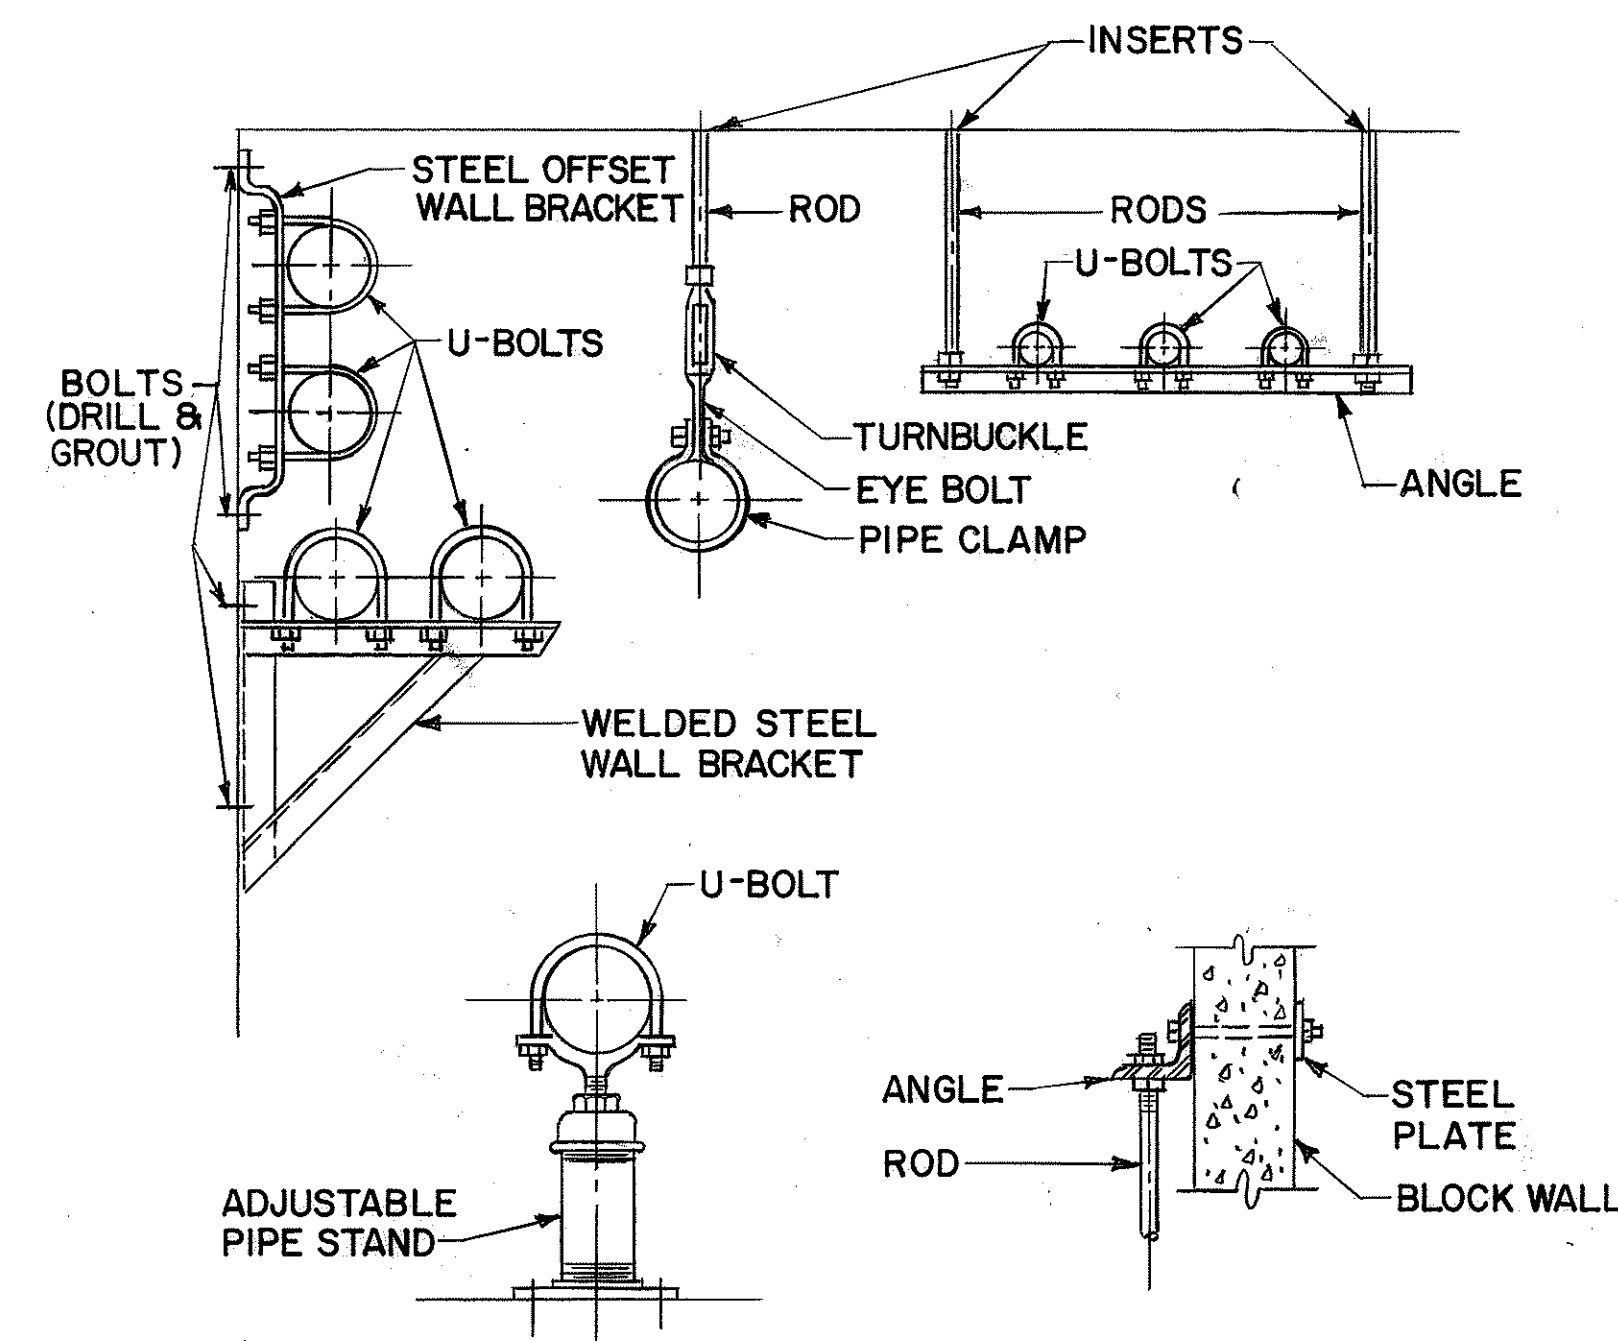

TYPICAL PIPE SUPPORTS

DETAIL 3
— M26

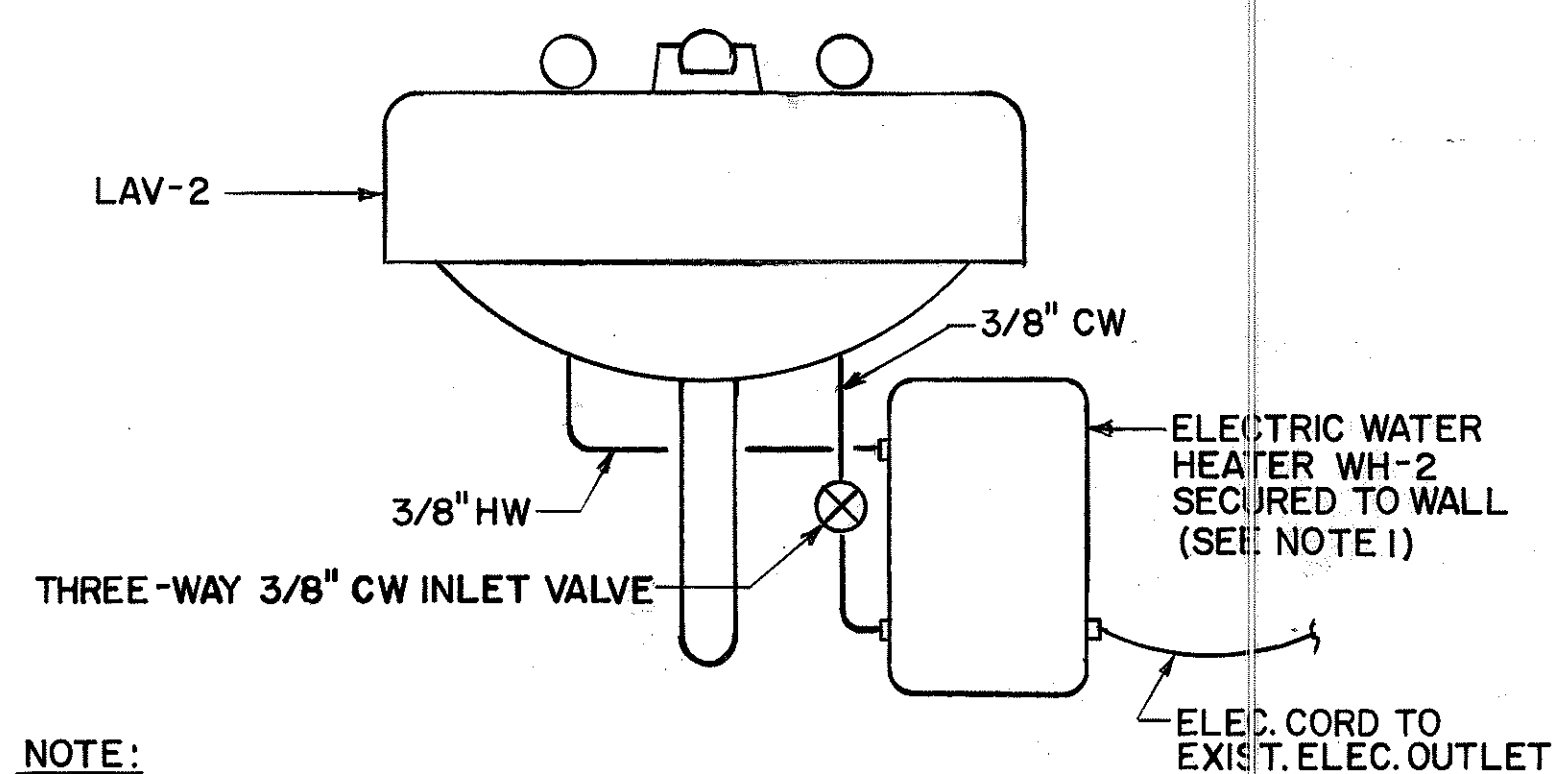


NOTE:
1- FOR ARCH. DWGS. OF PORTALS
TOILET ROOMS LOCATIONS SEE
SHTS. AN1, AO2, AM1 & AQ1

ELECTRIC WATER HEATER WH-2

DETAIL

4
— M26

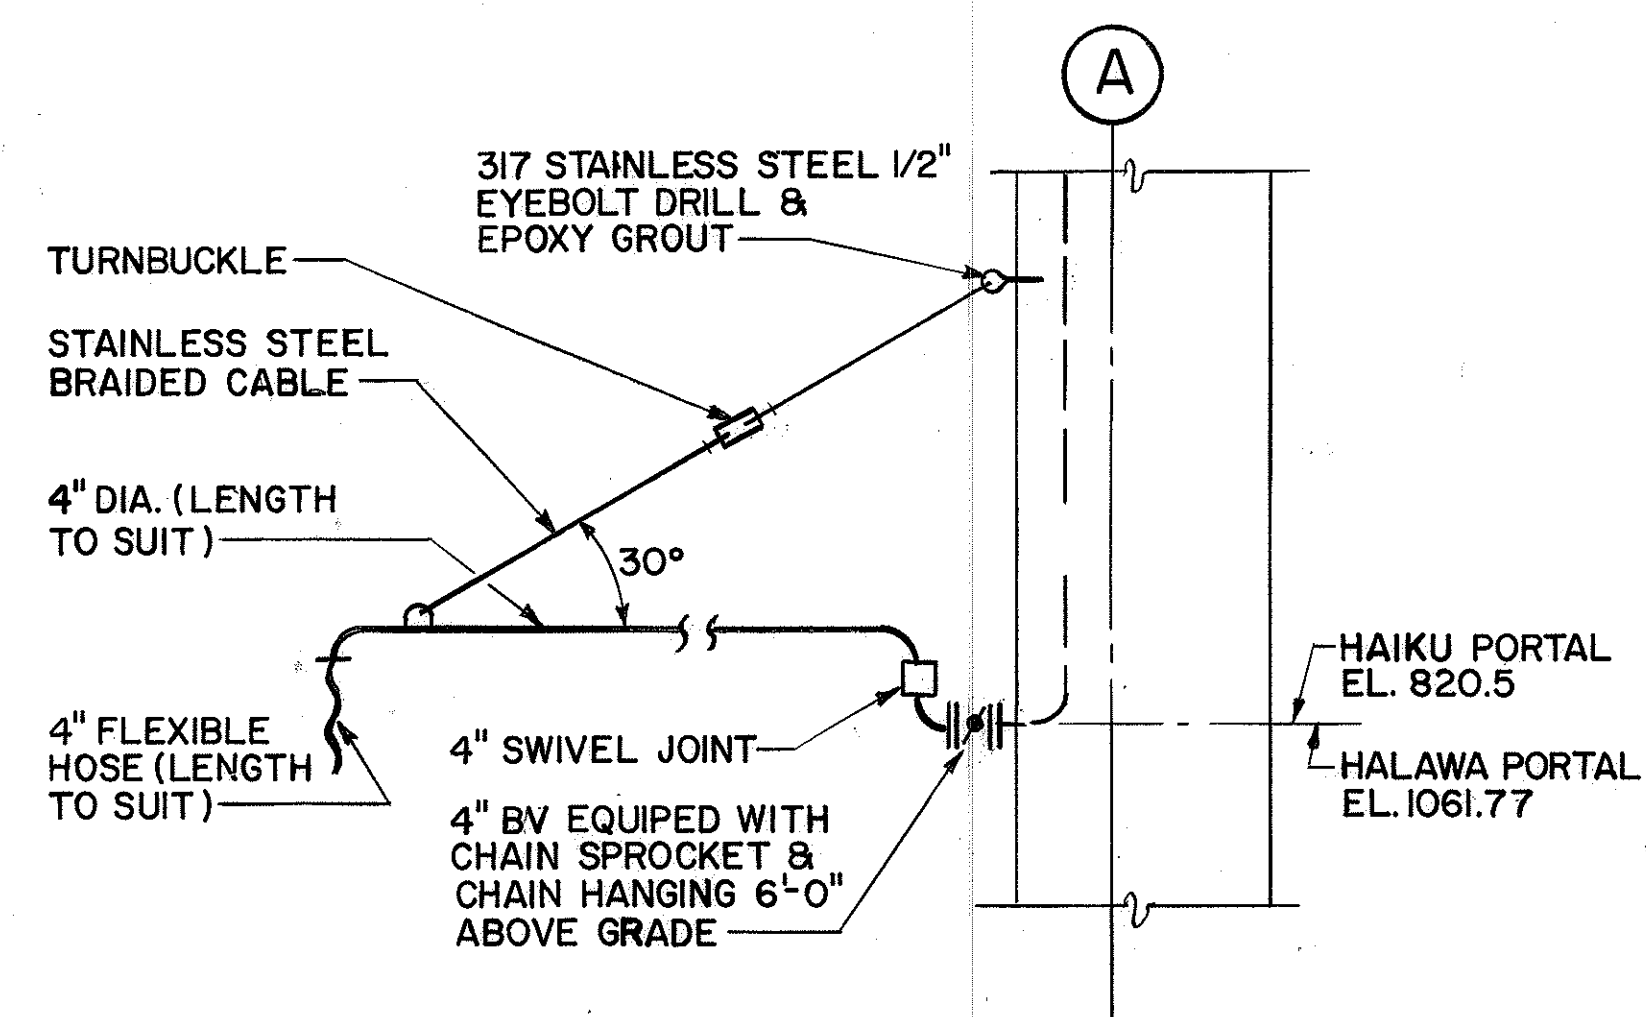

TRUCK WASH SWIVEL ARM

DETAIL 

[illegible]

STATE OF HAWAII
DEPARTMENT OF TRANSPORTATION
HIGHWAYS DIVISION

PLUMBING - DETAILS I STANDARDS

INTERSTATE ROUTE H-3
F.A.I. PROJ. NO. I-H3-1 (66)

SCALE : NO SCALE DATE : APR 1992
SHEET NO. M26 OF 28 SHEETS




THIS WORK WAS PREPARED BY ME
OR UNDER MY SUPERVISION

John R. ...


ORIGINAL PLAN	SURVEY PLOTTED BY DRAWN BY <u>P. L. ALAQUE</u>	DATE * <u>01/11/90</u>
NOTE BOOK	TRACED BY _____ DESIGNED BY <u>P. L. ALAQUE</u>	* <u>01/9/90</u>
	QUANTITIES BY _____	* _____
No. _____	CHECKED BY <u>J. N. QUE</u>	<u>06/05/90</u>

FED. ROAD DIST. NO.	STATE	FED. AID PROJ. NO.	FISCAL YEAR	SHEET NO.	TOTAL SHEETS
HAWAII	HAW.	I-H3-1(66)	1992	37	440

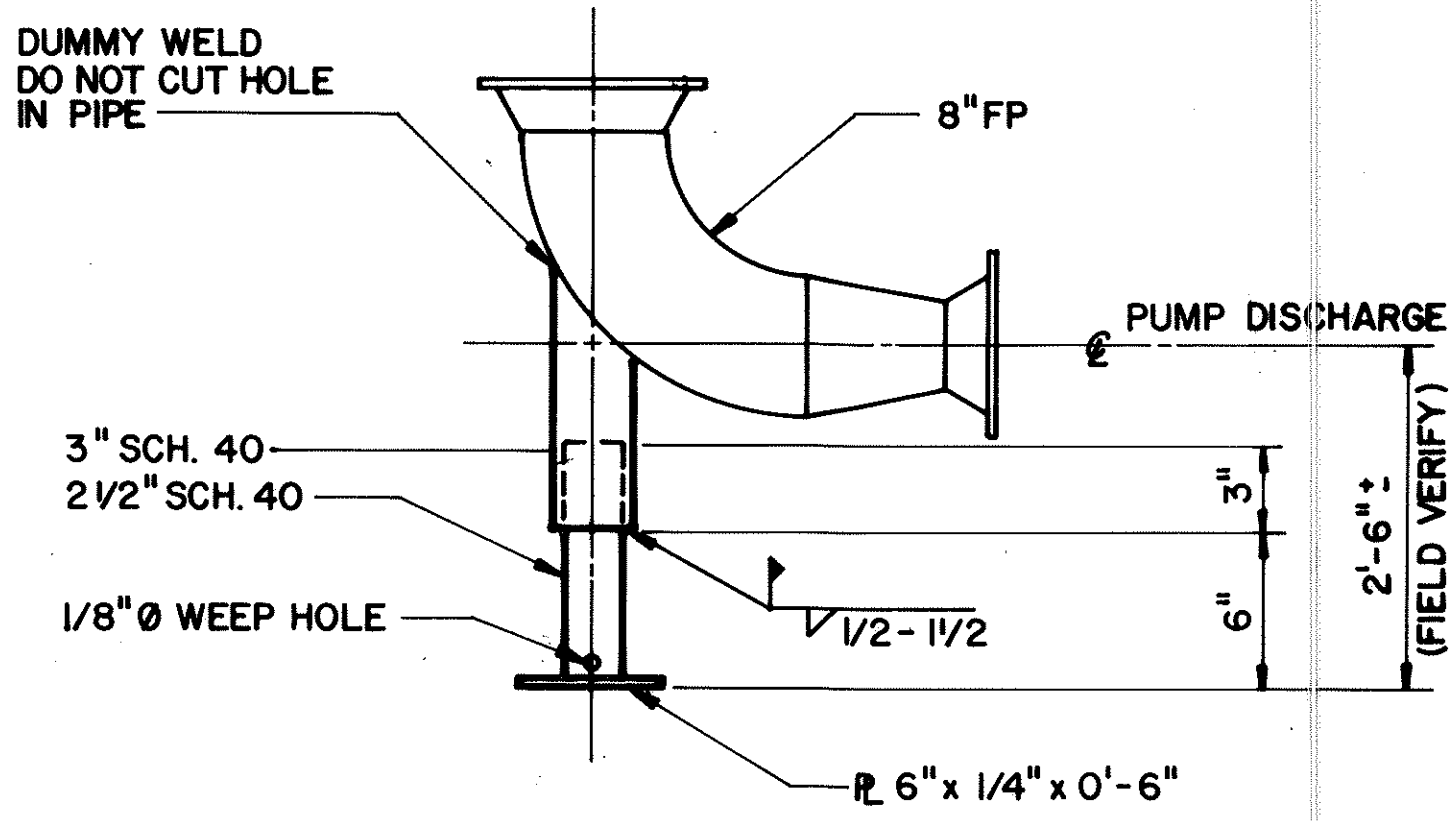


FIRE PUMP DISCHARGE PIPE SUPPORT DETAIL

M27

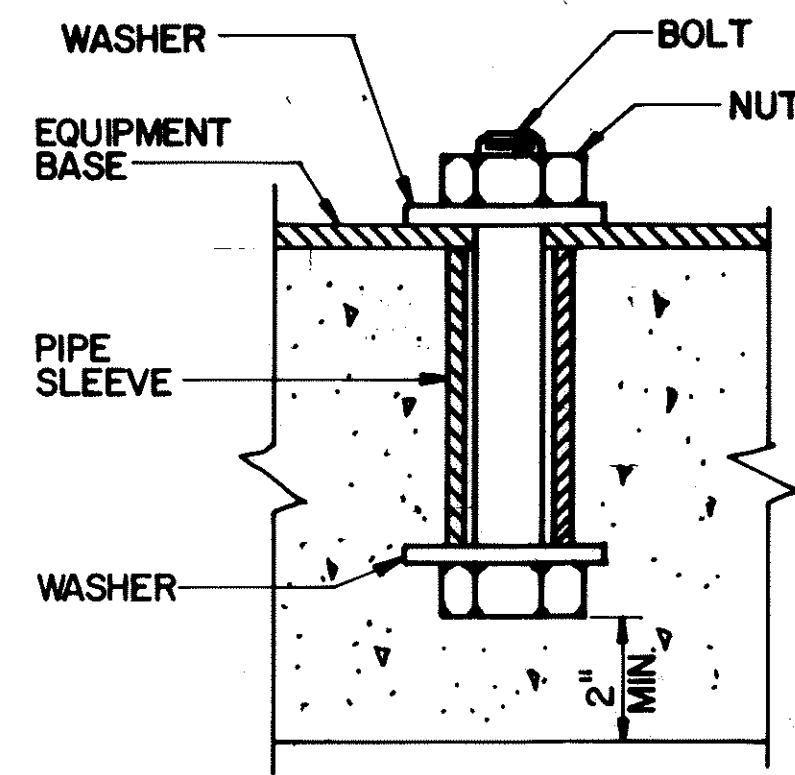

BOLT SIZE	PIPE SIZE		AW. STD. FLAT WSHR
	SCH. 40 I.D.	MIN. LGTH.	
3/8	1/2	4	1 3/8
1/2	3/4	6	1 3/8
5/8	3/4	6	1 3/4
3/4	1	6	2
7/8	1	6	2
1	1 1/4	8	2 1/4

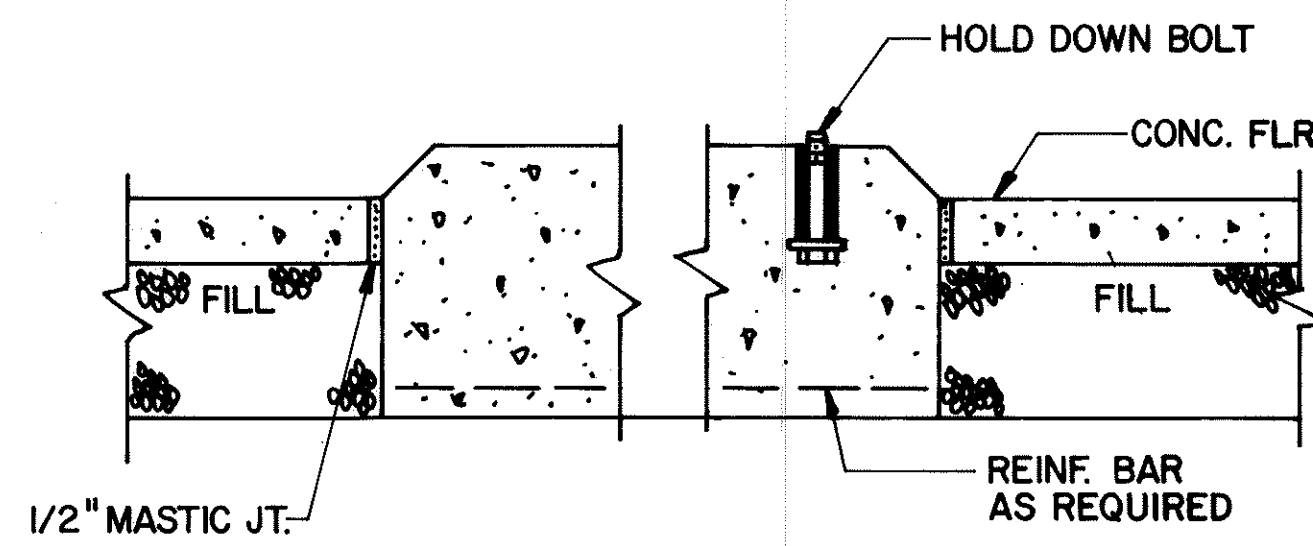

EQUIPMENT FOUNDATION

2
M27

ORIGINAL PLAN	DATE
NO.	17/9/89
SURVEY PLOTTED BY	DATE
DRAWN BY	17/9/89
DESIGNED BY	17/7/89
QUANTITIES BY	
CHECKED BY	06/05/90

THIS WORK WAS PREPARED BY ME OR UNDER MY SUPERVISION

John M. Que

DATE	REVISION

STATE OF HAWAII
DEPARTMENT OF TRANSPORTATION
HIGHWAYS DIVISION


**PLUMBING -
DETAILS 2
STANDARDS**

INTERSTATE ROUTE H-3
F.A.I. PROJ. NO. I-H3-1 (66)



SCALE: NO SCALE DATE: APR 1992

SHEET NO. M27 OF 28 SHEETS


FED. ROAD DIST. NO.	STATE	FED. AID PROJ. NO.	FISCAL YEAR	SHEET NO.	TOTAL SHEETS
HAWAII	HAW.	I-H3-1(66)	1992	38	440

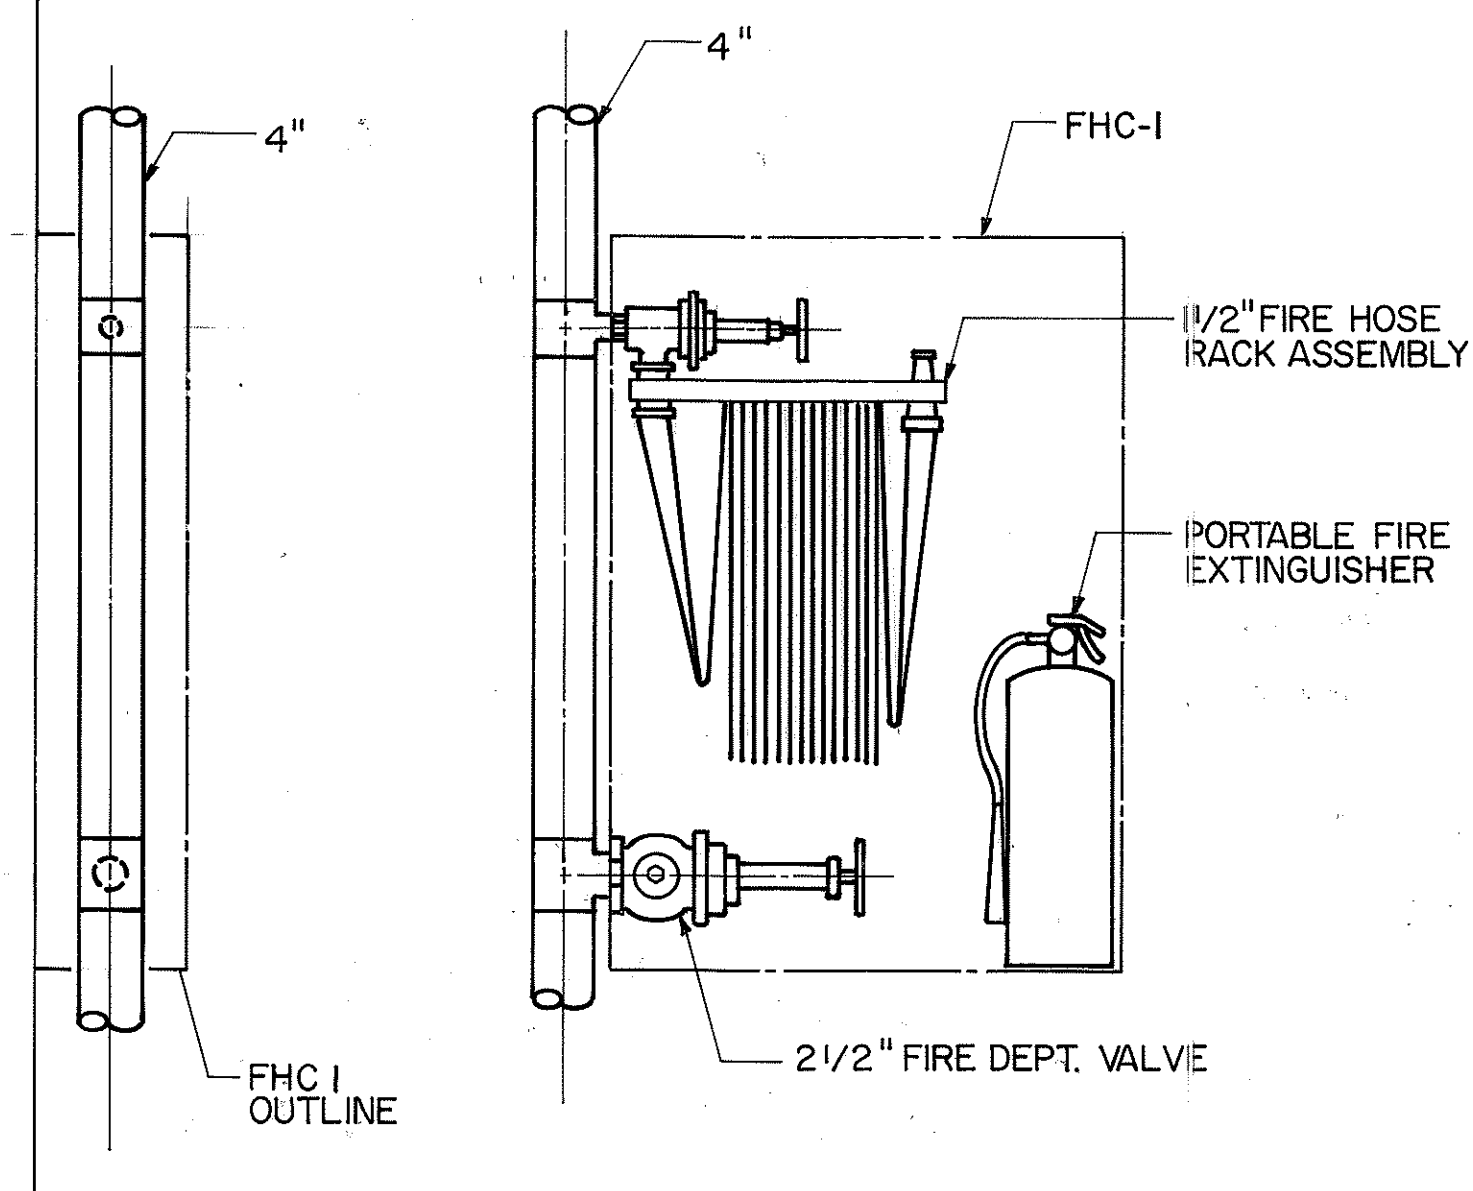


FIRE HOSE ASSEMBLY FHC-1 DETAIL
N.T.S.

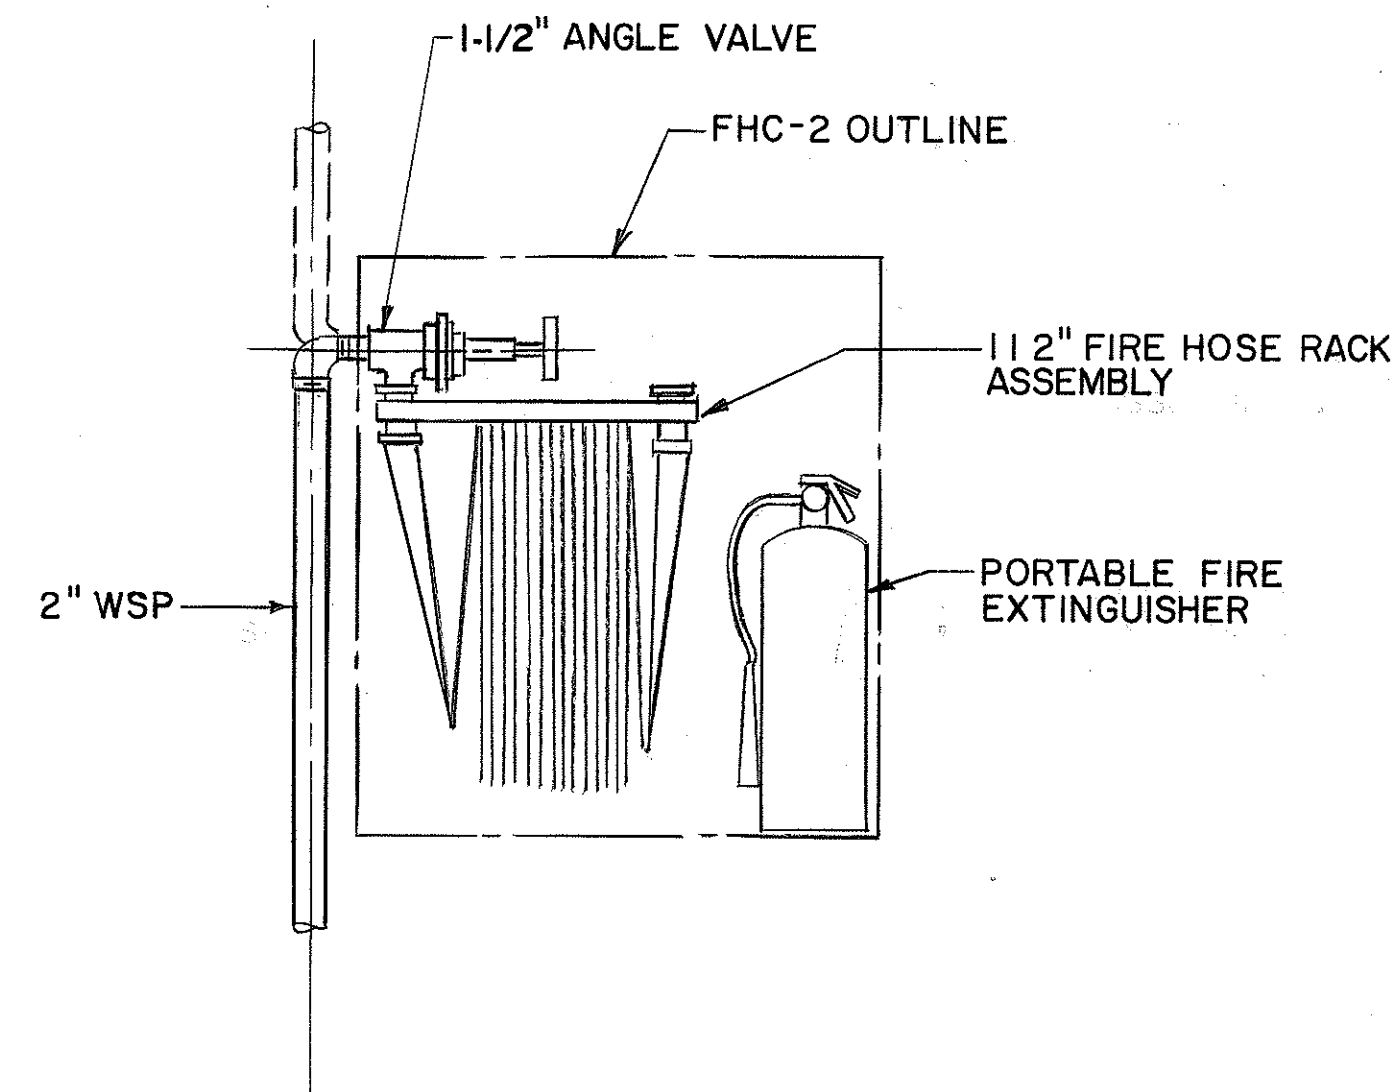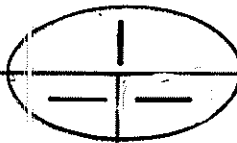

FIRE HOSE ASSEMBLY FHC-2 DETAIL
N.T.S.

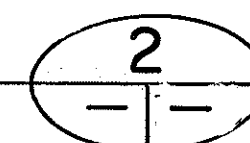

ORIGINAL PLAN	DATE
DESIGNED BY	12/26/88
TRACED BY	12/21/89
NOTED BY	06/05/90
CHECKED BY	

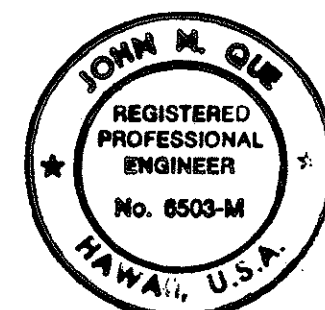

THIS WORK WAS PREPARED BY ME
OR UNDER MY SUPERVISION

John M. Que


STATE OF HAWAII
DEPARTMENT OF TRANSPORTATION
HIGHWAYS DIVISION

**FIRE PROTECTION
DETAILS**



STANDARDS
INTERSTATE ROUTE H-3
F.A.I. PROJ. NO. I-H3-1 (66)

SCALE: NO SCALE DATE: APR 1992
SHEET NO. M28 OF 28 SHEETS


FED. ROAD DIST. NO.	STATE	FED. AID PROJ. NO.	FISCAL YEAR	SHEET NO.	TOTAL SHEETS
HAWAII	HAW.	I - H3 - I (66)	1992	40	440

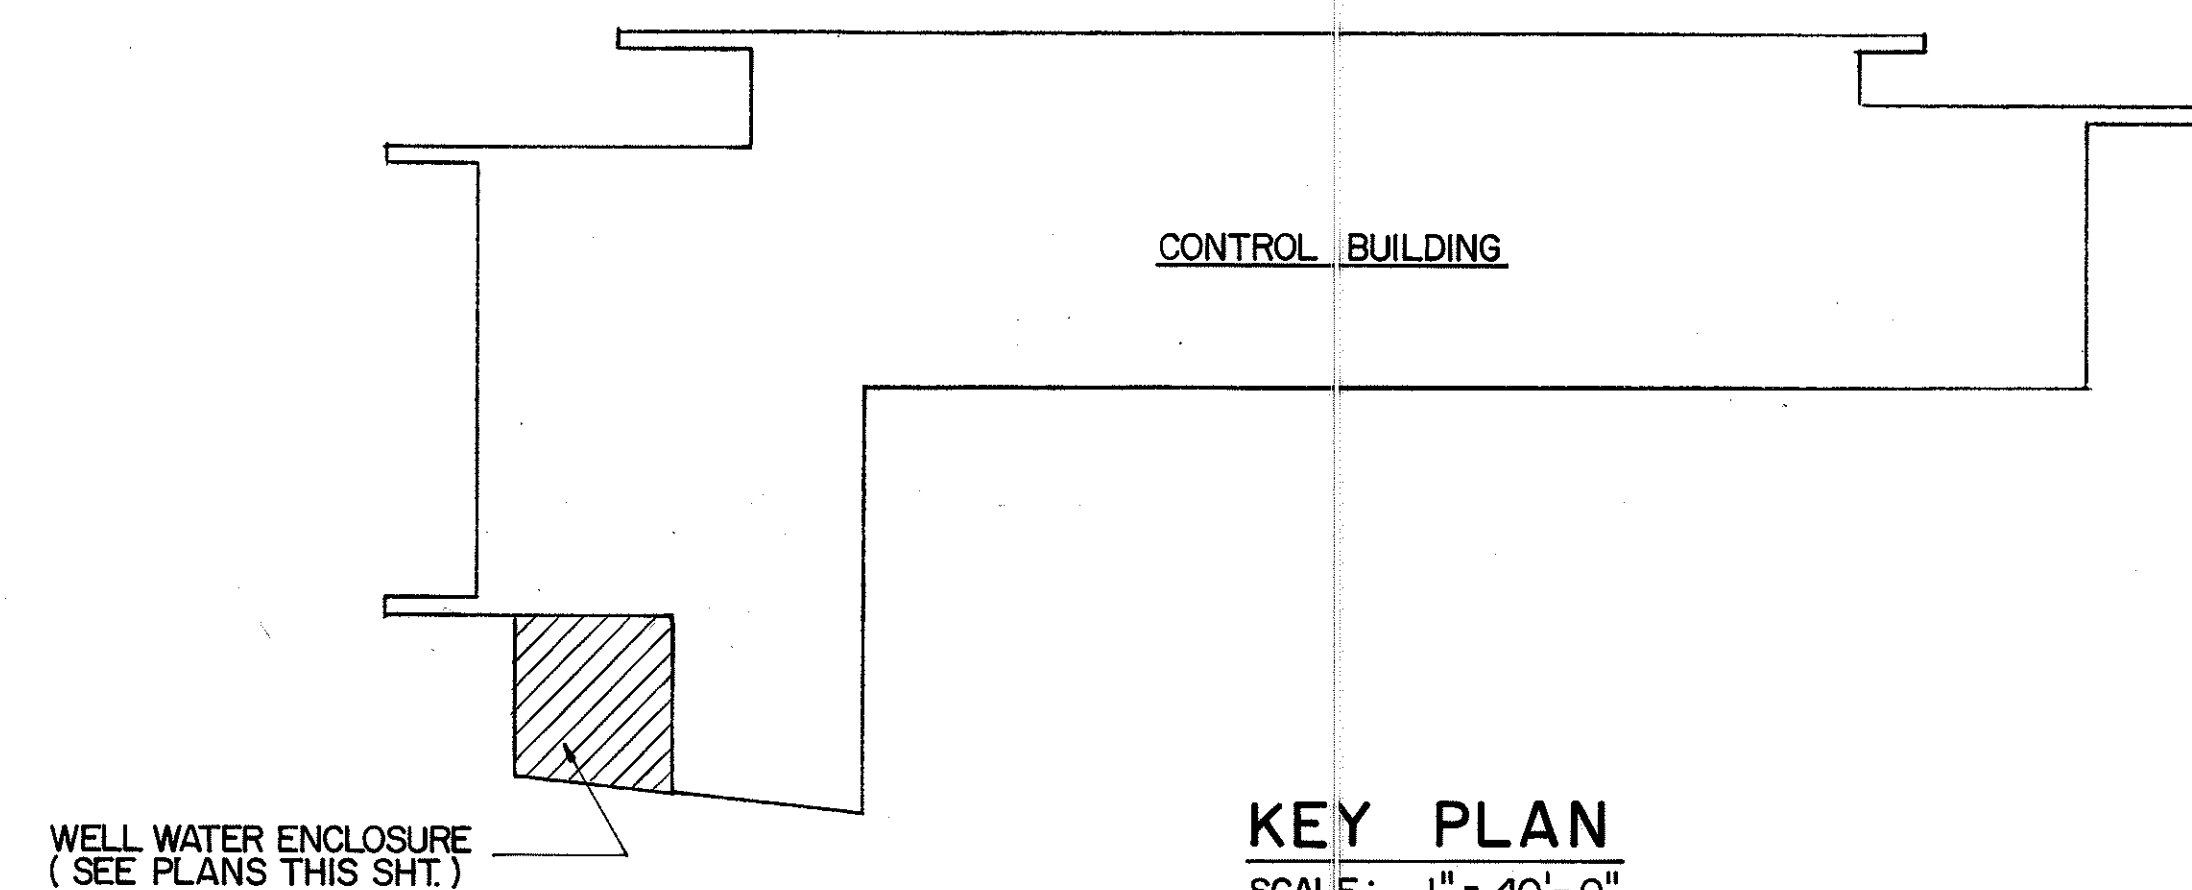


KEY PLAN
SCALE: 1" = 40'-0"

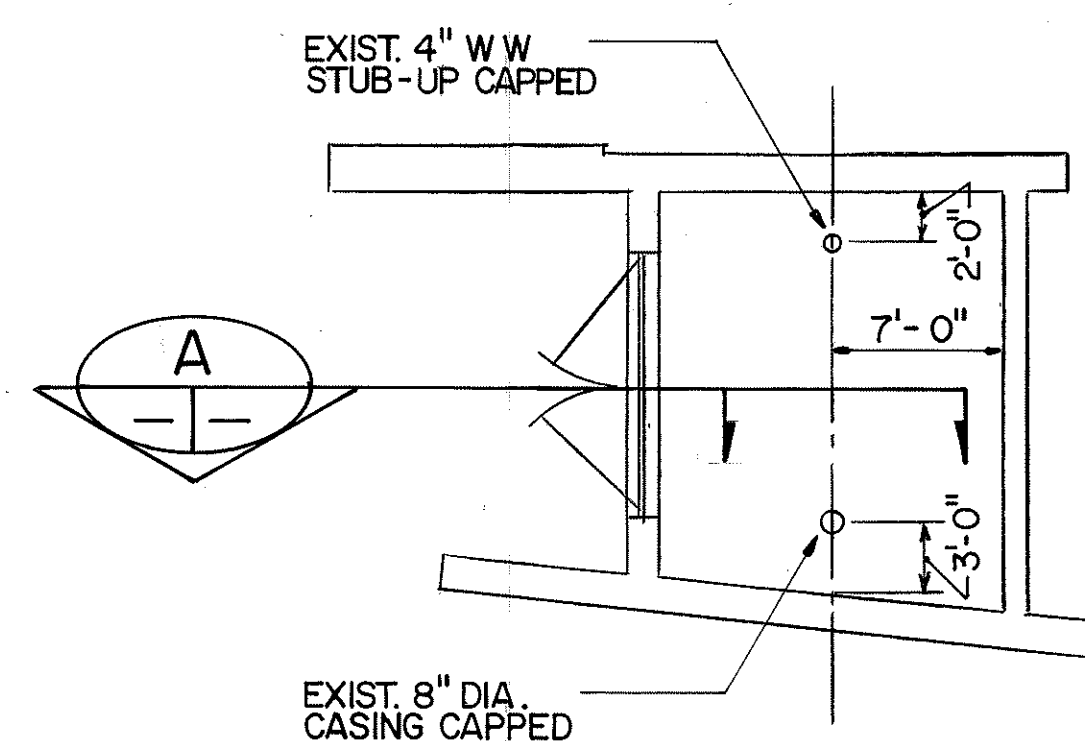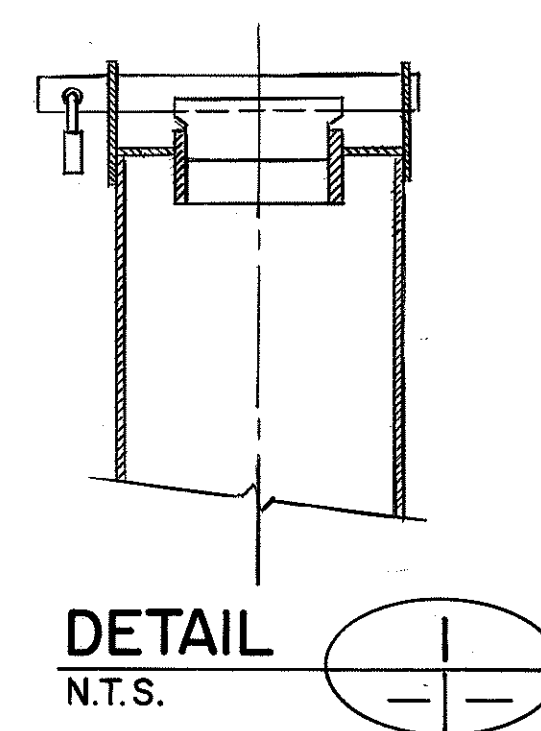


EXIST. WATER WELL ENCLOSURE PLAN
SCALE: 1/8" = 1'-0"

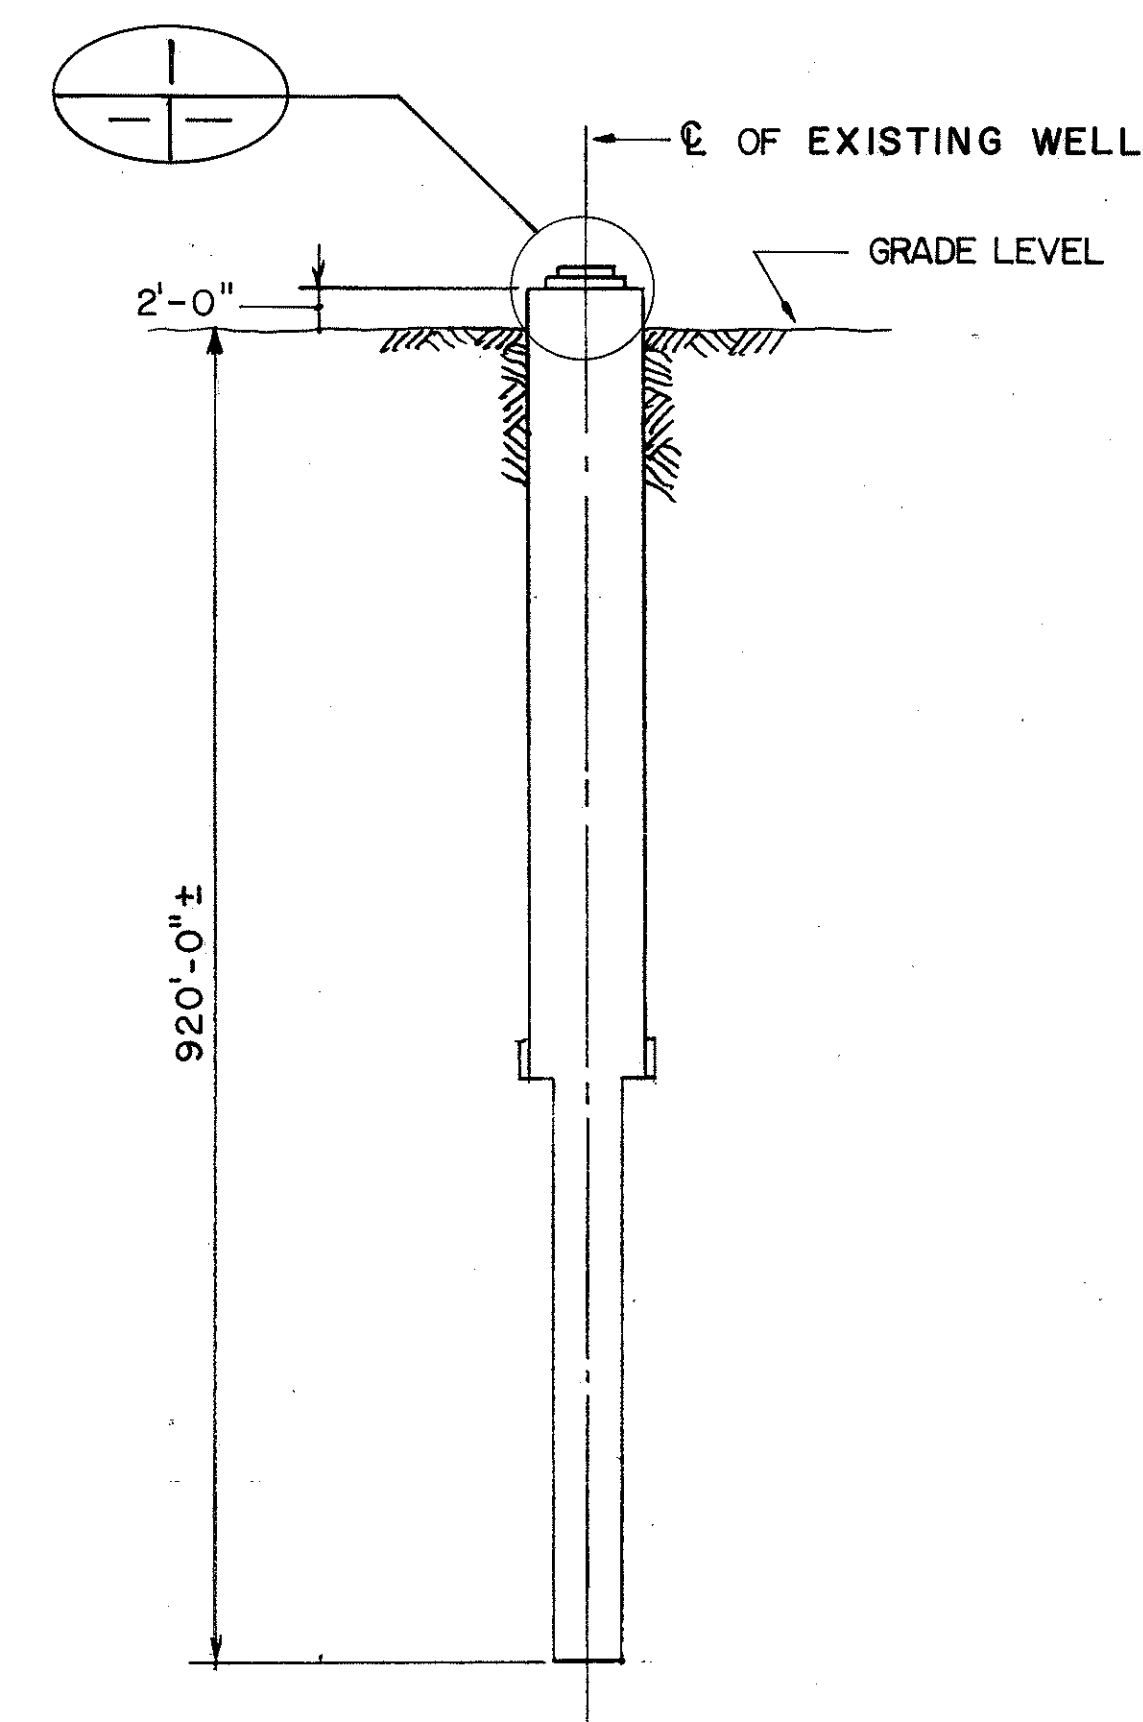

SECTION
N.T.S.

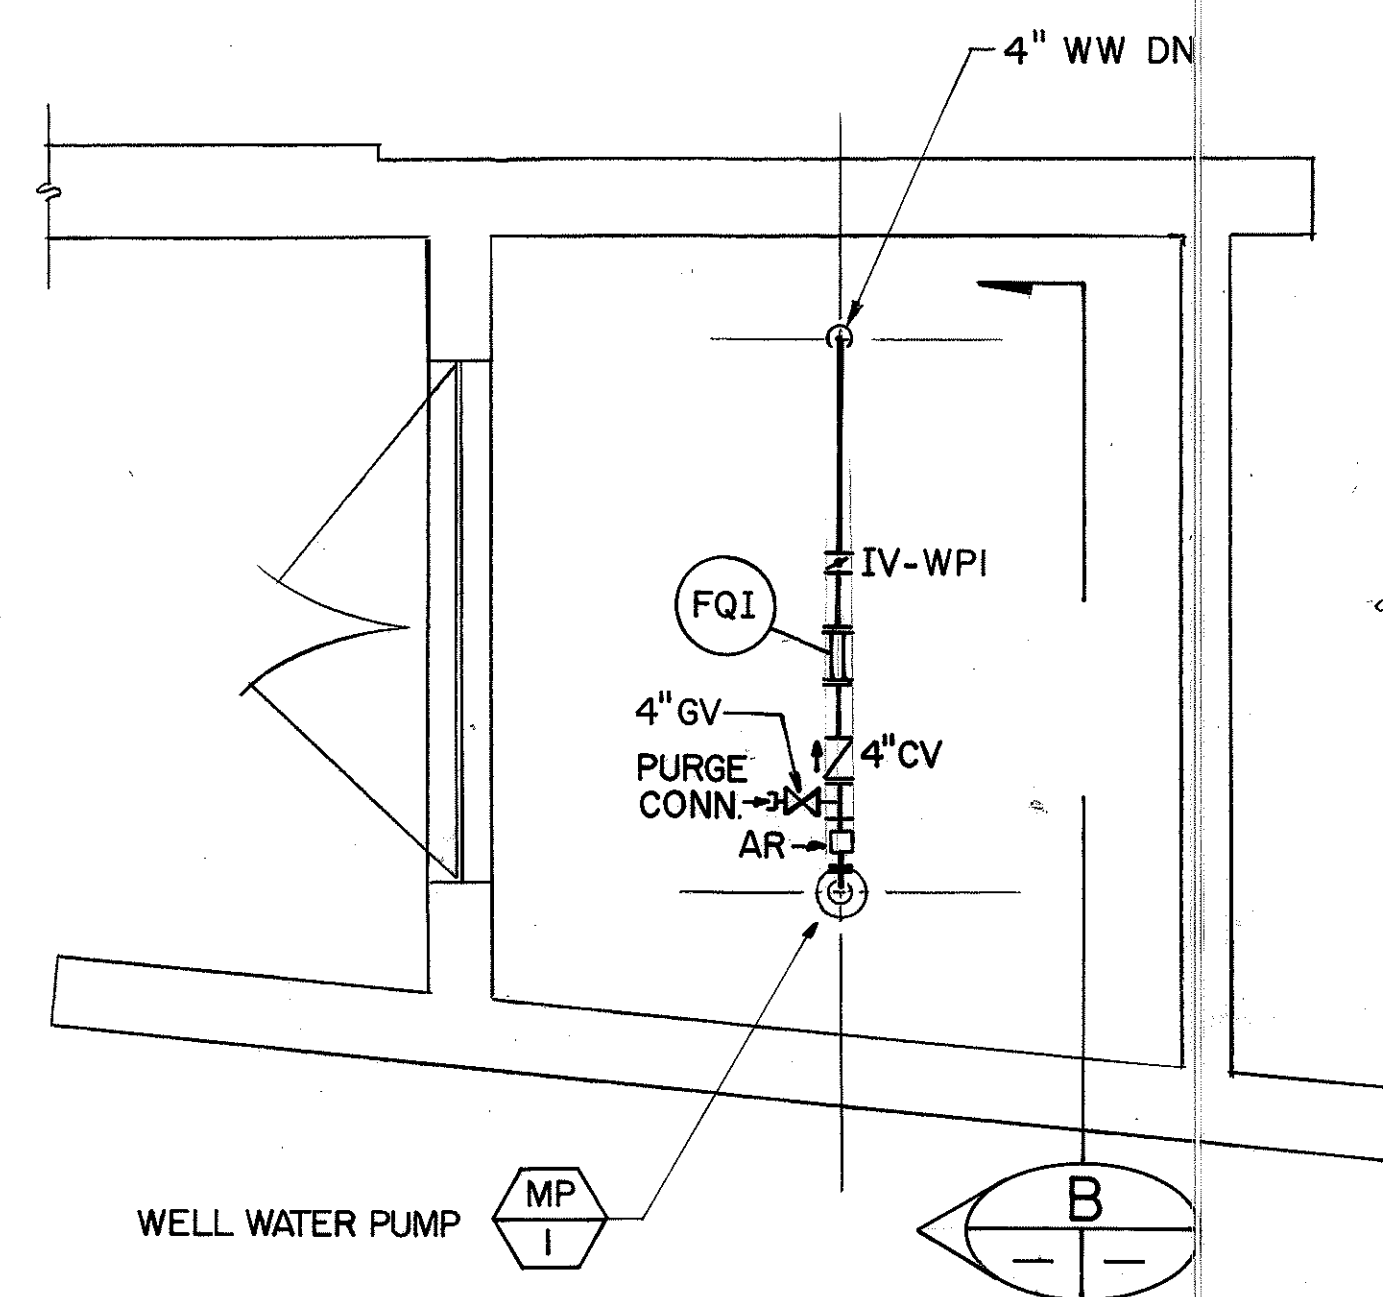


WELL WATER PUMP & PIPING PLAN
SCALE: 1/4" = 1' - 0"

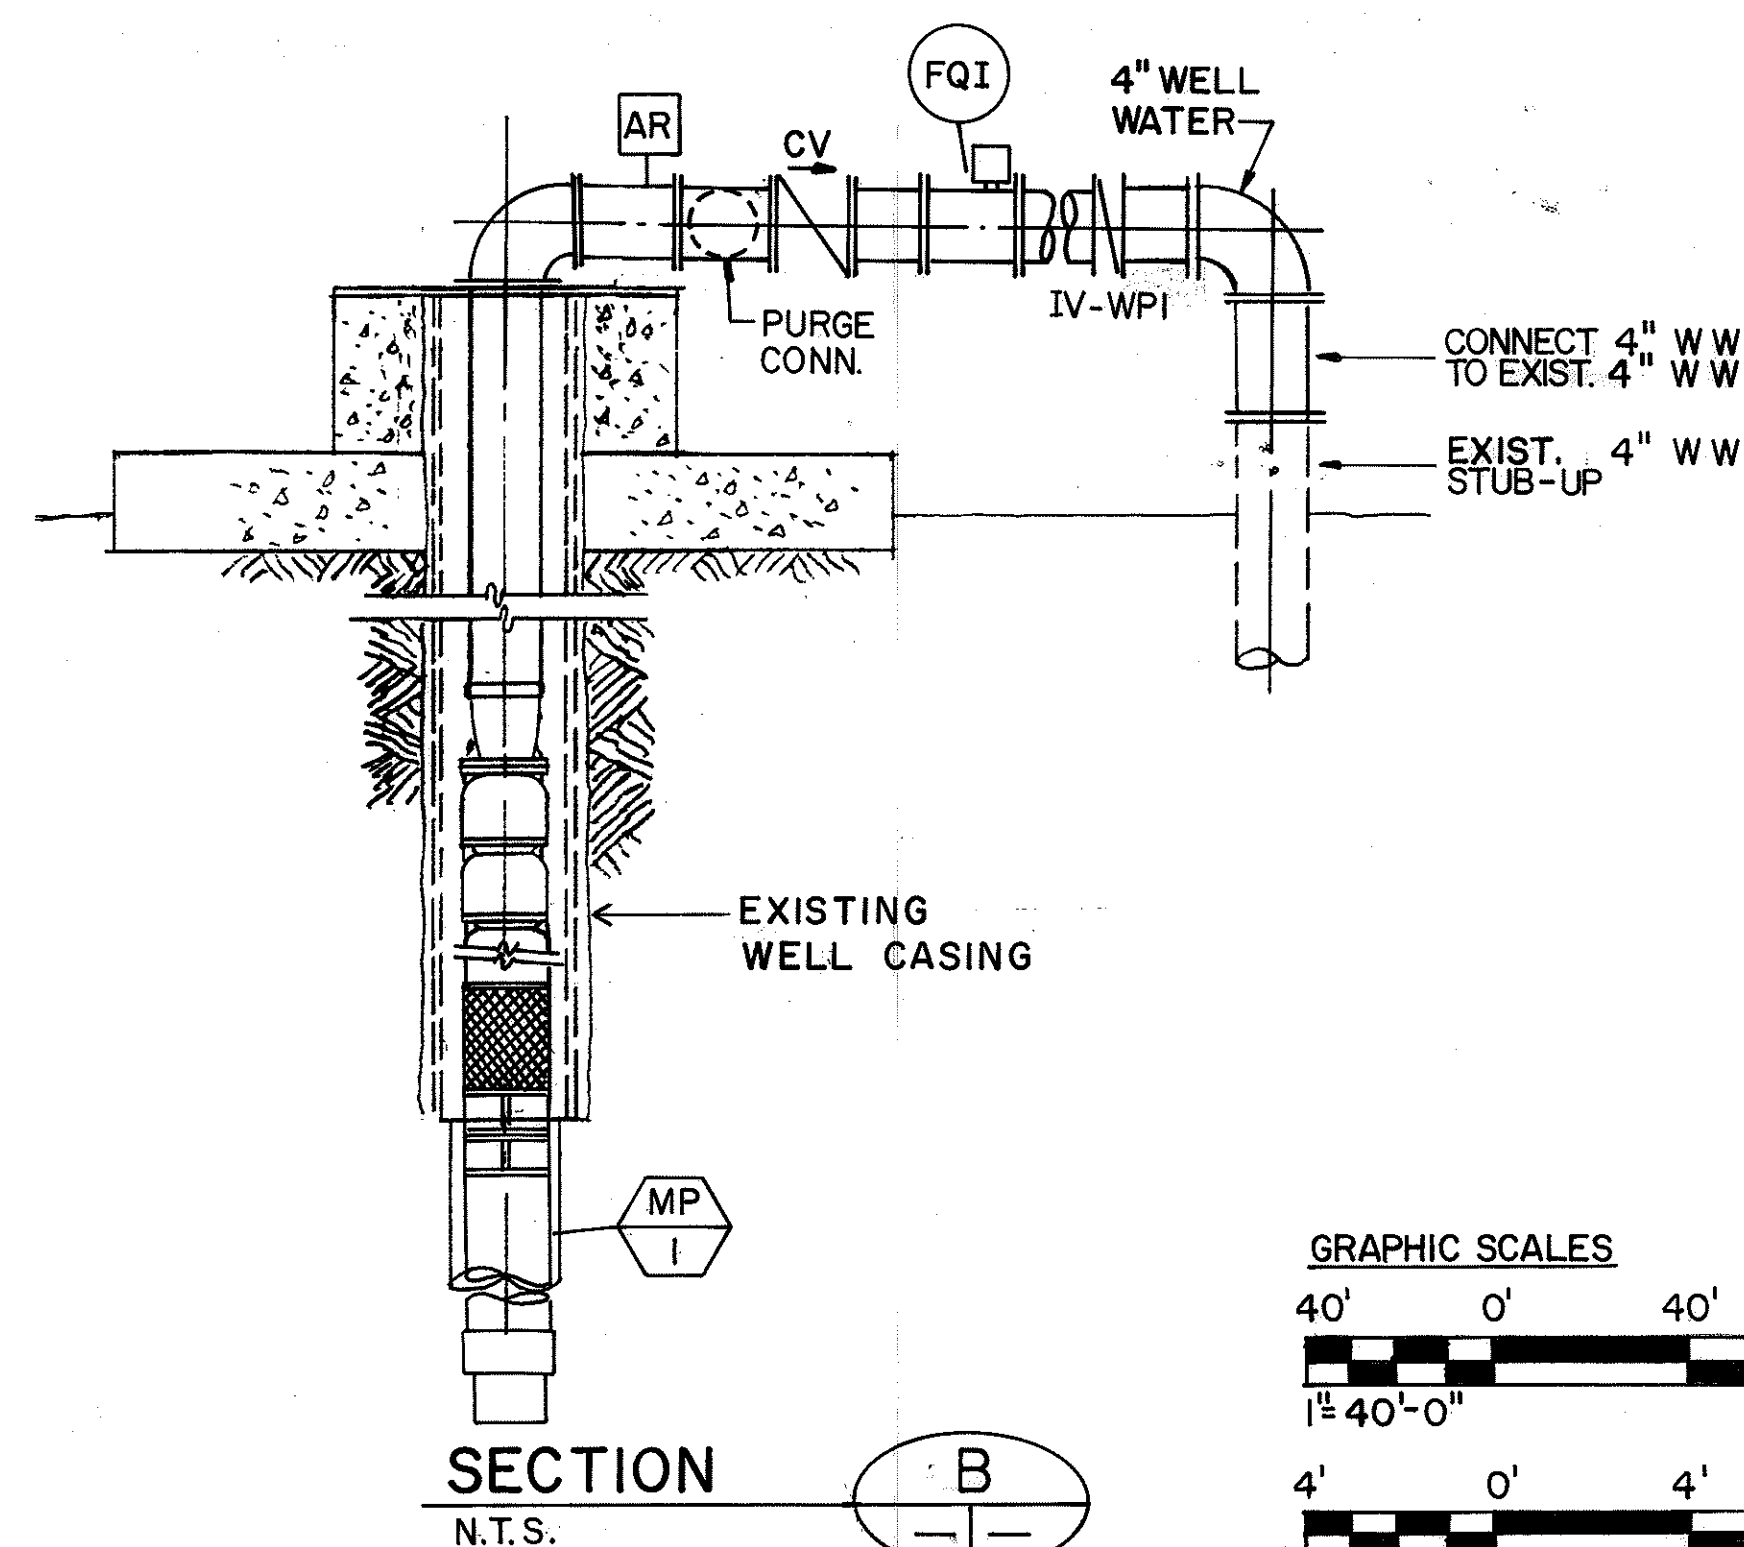

SECTION
N.T.S.

GRAPHIC SCALES

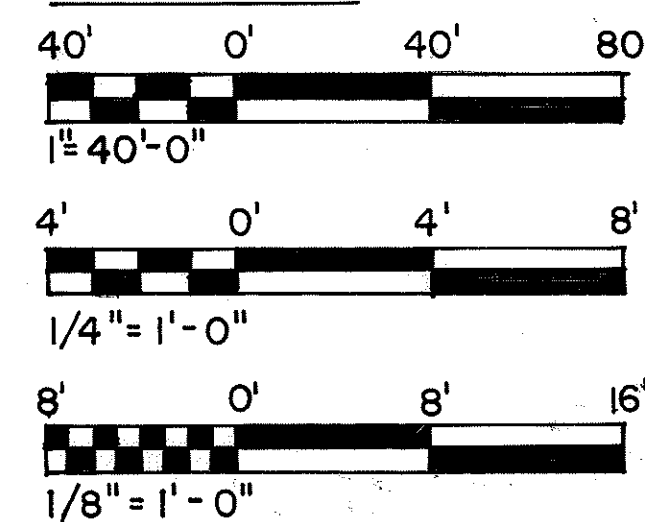

THIS WORK WAS PREPARED BY ME
OR UNDER MY SUPERVISION

DATE	REVISION

STATE OF HAWAII

DEPARTMENT OF TRANSPORTATION

HIGHWAYS DIVISION

PLUMBING - WELL WATER PUMP

PLAN & SECTION

HALAWA APPROACH


INTERSTATE ROUTE H-3

F.A.I. PROJ. NO. I-H3-1 (66)


SCALE : AS NOTED
DATE : APR 1992

SHEET NO. MA2 OF 2 SHEETS

FED. ROAD DIST. NO.	STATE	FED. AID PROJ. NO.	FISCAL YEAR	SHEET NO.	TOTAL SHEETS
HAWAII	HAW.	I - H3 - I (66)	1992	41	440

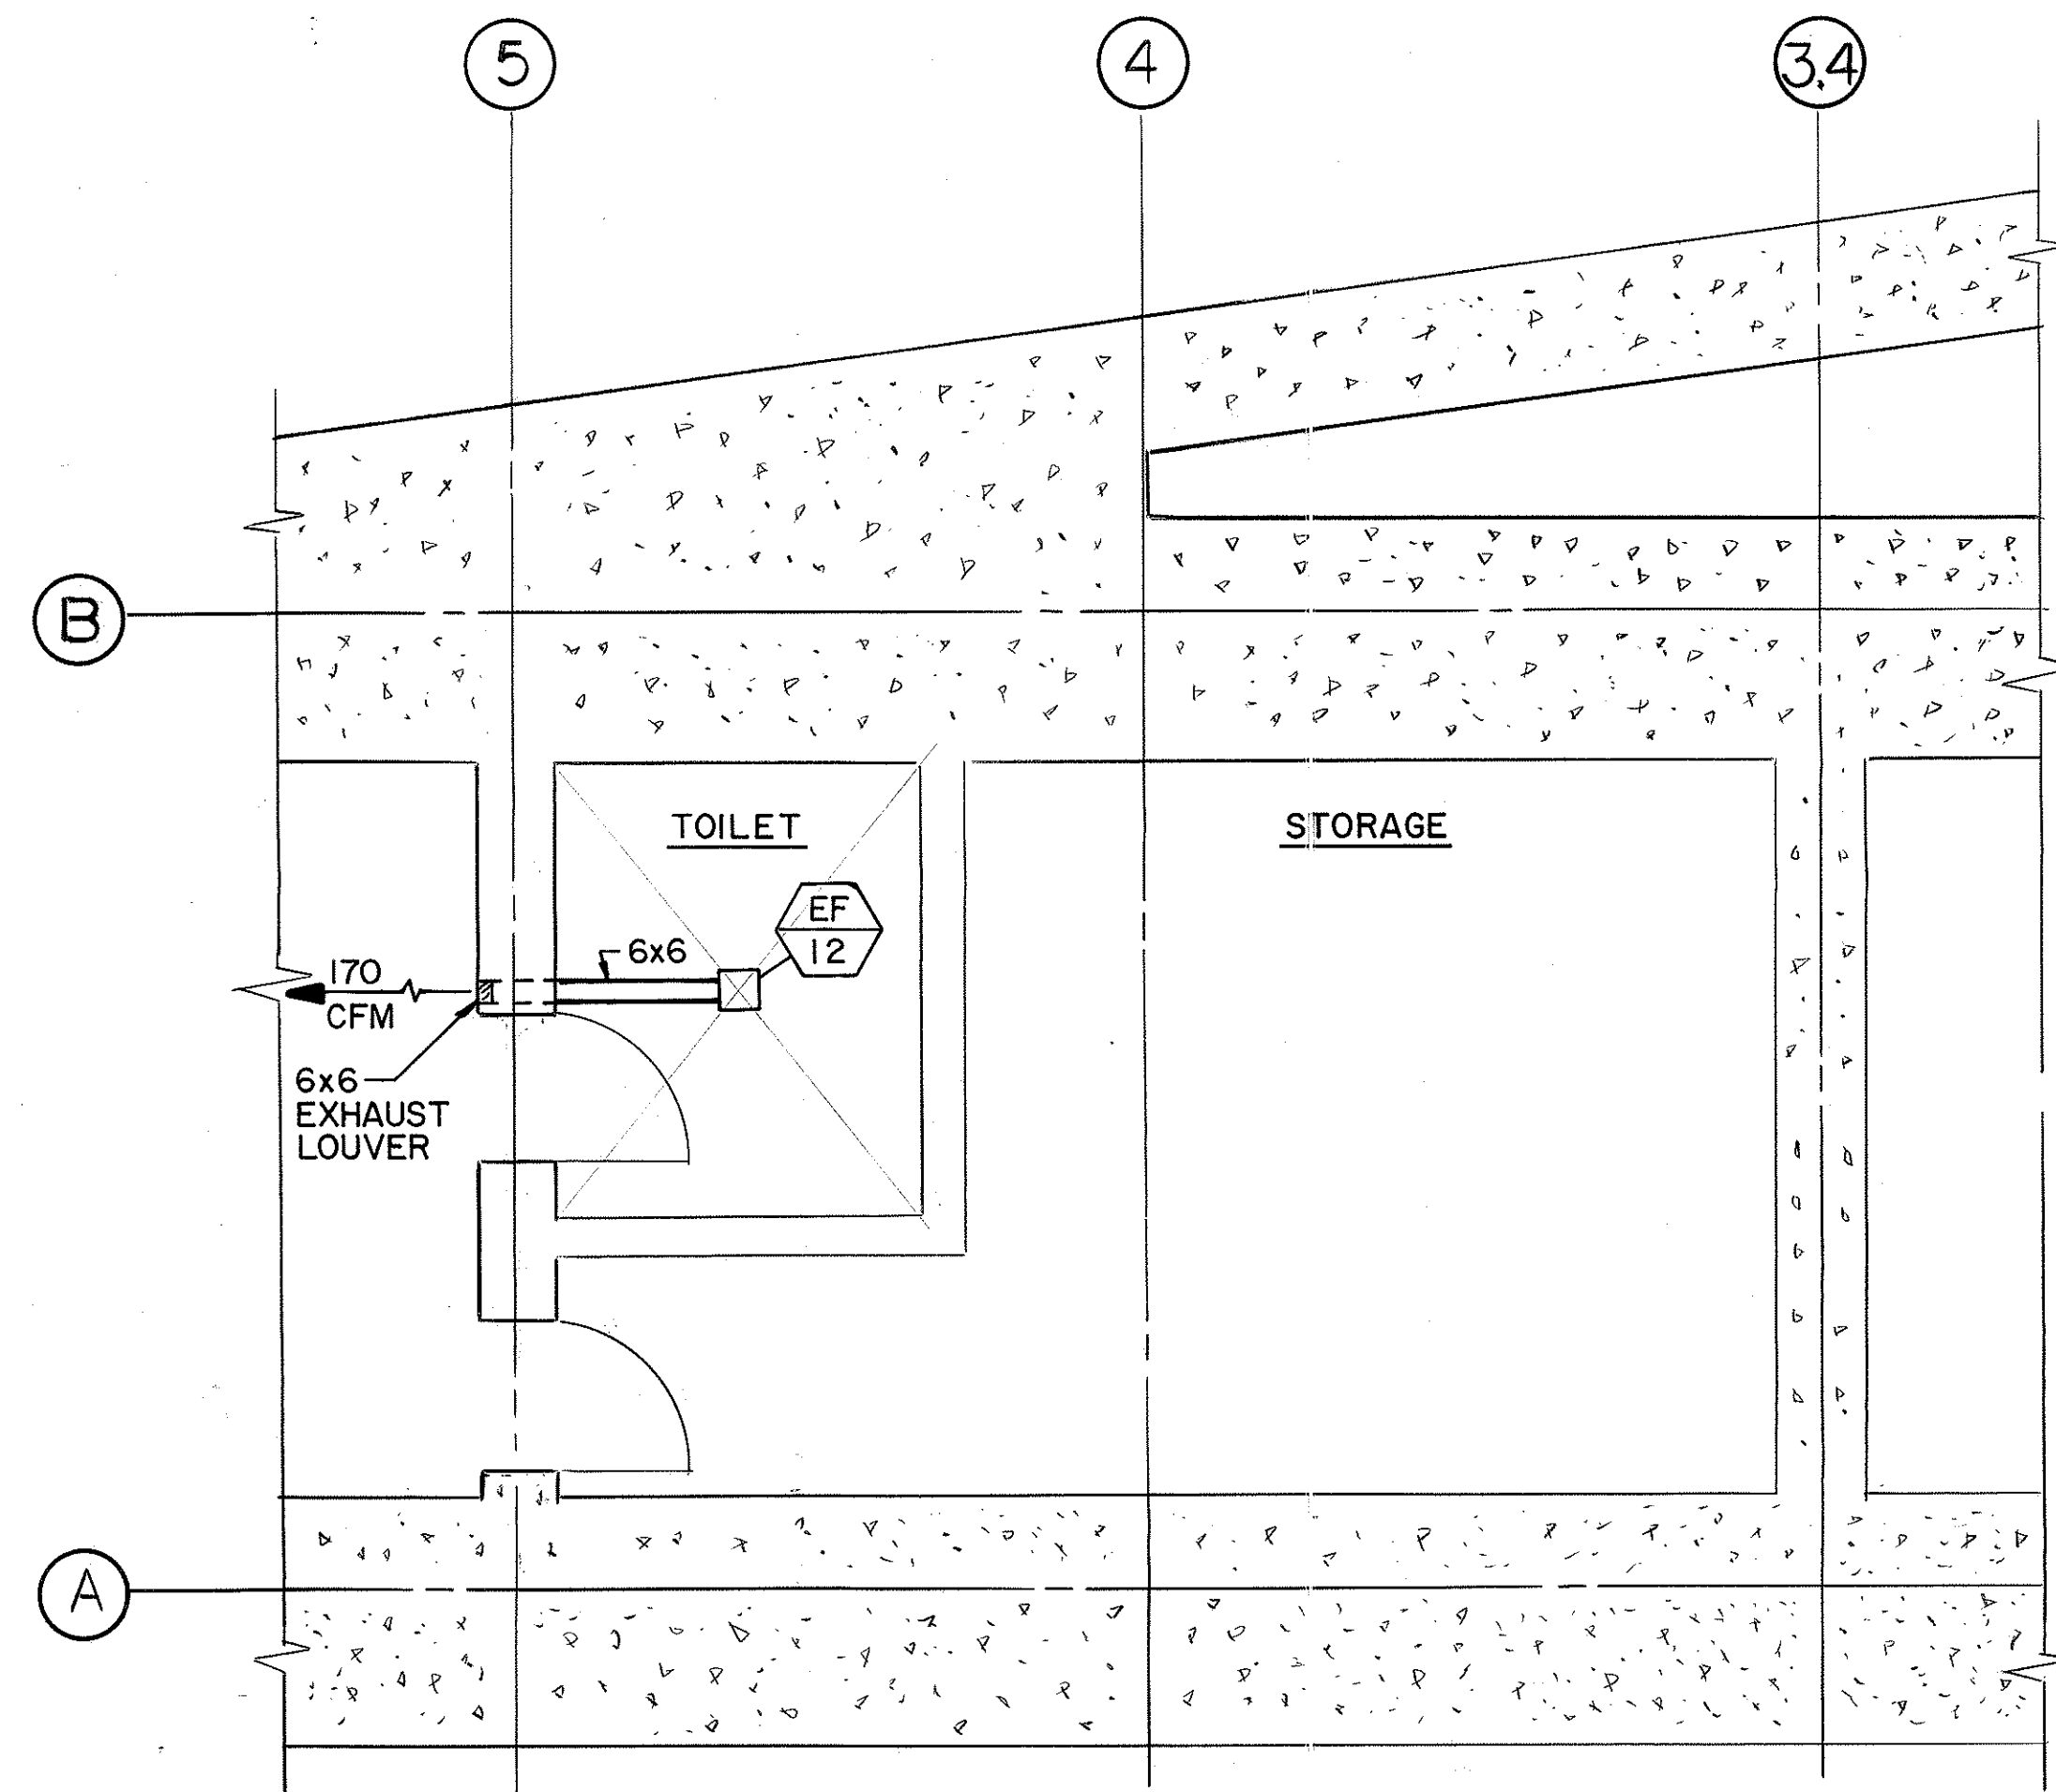

LEVEL I PARTIAL PLAN

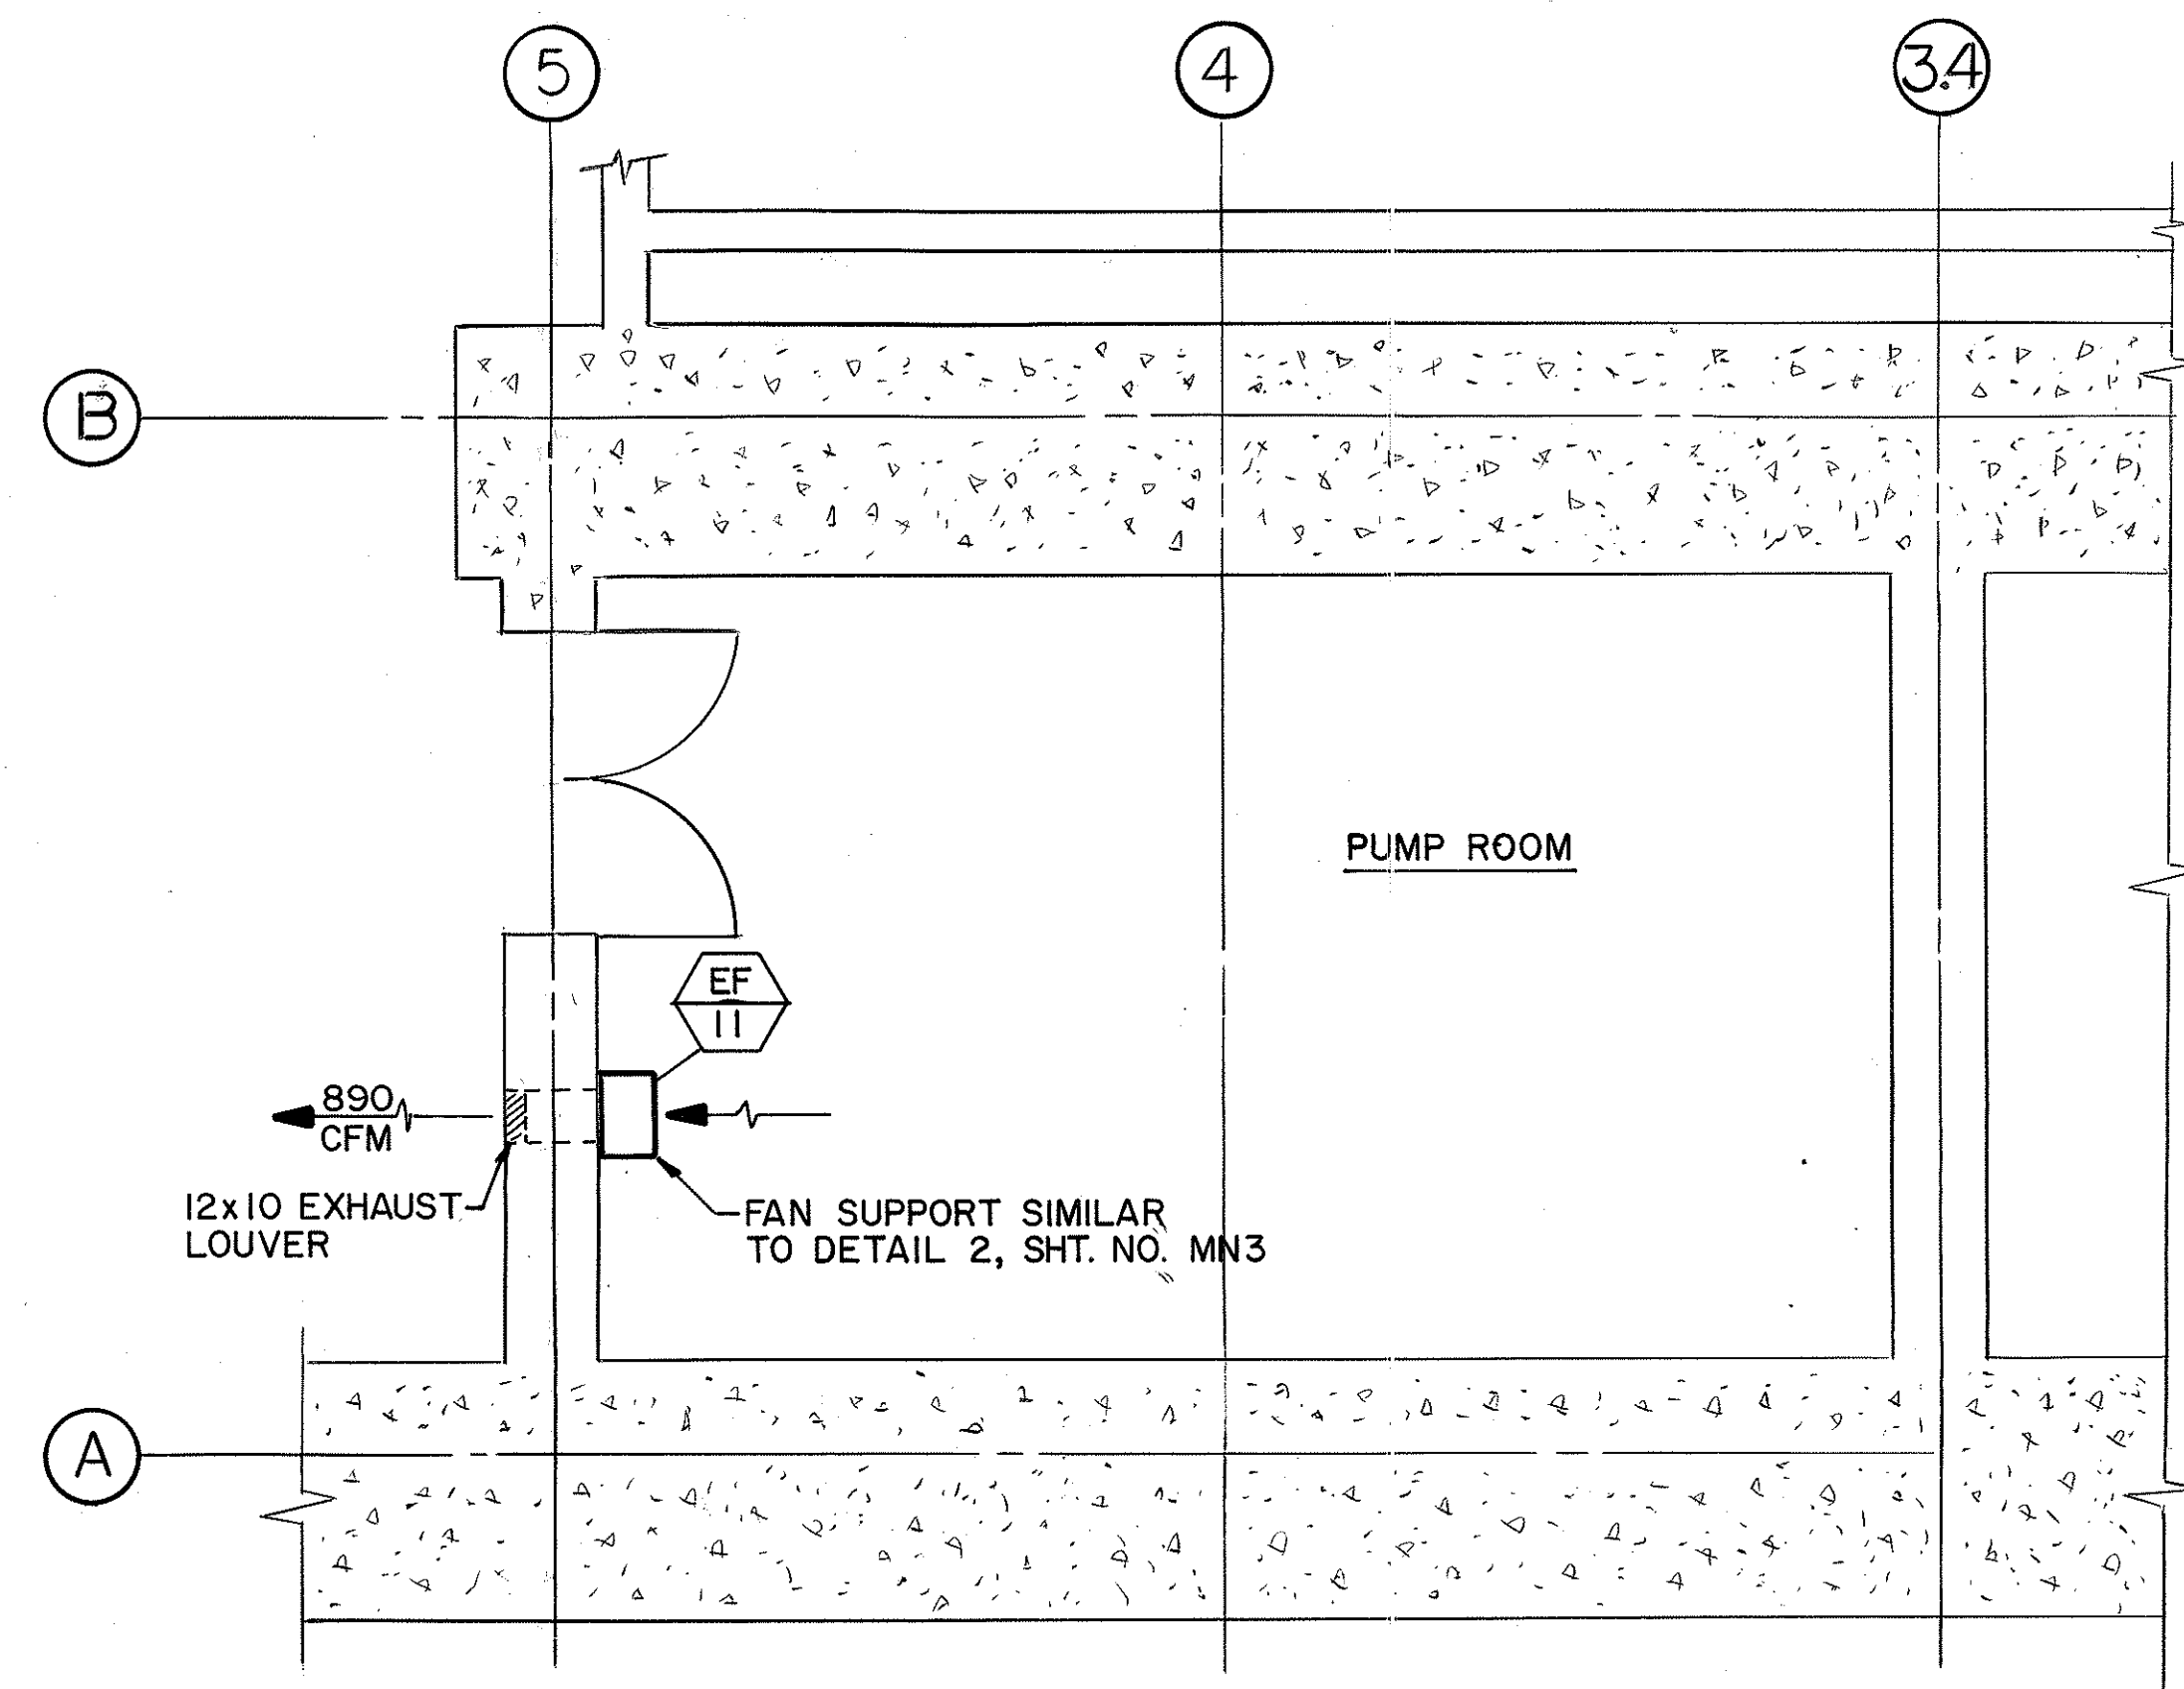

LEVEL 2 PARTIAL PLAN


FOR DETAIL AS-BUILT INFORMATION
REFER TO CONSTRUCTION SUBMITTALS

DATE	REVISION

STATE OF HAWAII
DEPARTMENT OF TRANSPORTATION
HIGHWAYS DIVISION

HVAC - LEVEL 1
& LEVEL 2 PARTIAL PLANS
HALAWA PORTAL BUILDING - IB
INTERSTATE ROUTE H-3
F.A.I. PROJ. NO. I-H3-I (66)

SCALE: 1/4" = 1' - 0" DATE: APR 1992
SHEET NO. MNI OF 8 SHEETS

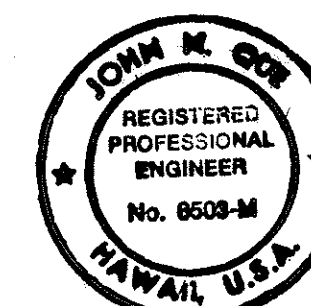


THIS WORK WAS PREPARED BY ME
OR UNDER MY SUPERVISION

John D. ...


GRAPHIC SCALE
1' 0" 1' 2" 3' 4' 5"
1/4" = 1'-0"

ORIGINAL PLAN	SURVEY PLOTTED BY DRAWN BY R. ANG	DATE 5/15/90
NOTE BOOK	DESIGNED BY D. E. DRYDEN	5/10/90
	QUANTITIES BY	
No.	CHECKED BY J. N. QUE	5/11/90

FED. ROAD DIST. NO.	STATE	FED. AID PROJ. NO.	FISCAL YEAR	SHEET NO.	TOTAL SHEETS
HAWAII	HAW.	I-H3-1(66)	1992	42	440

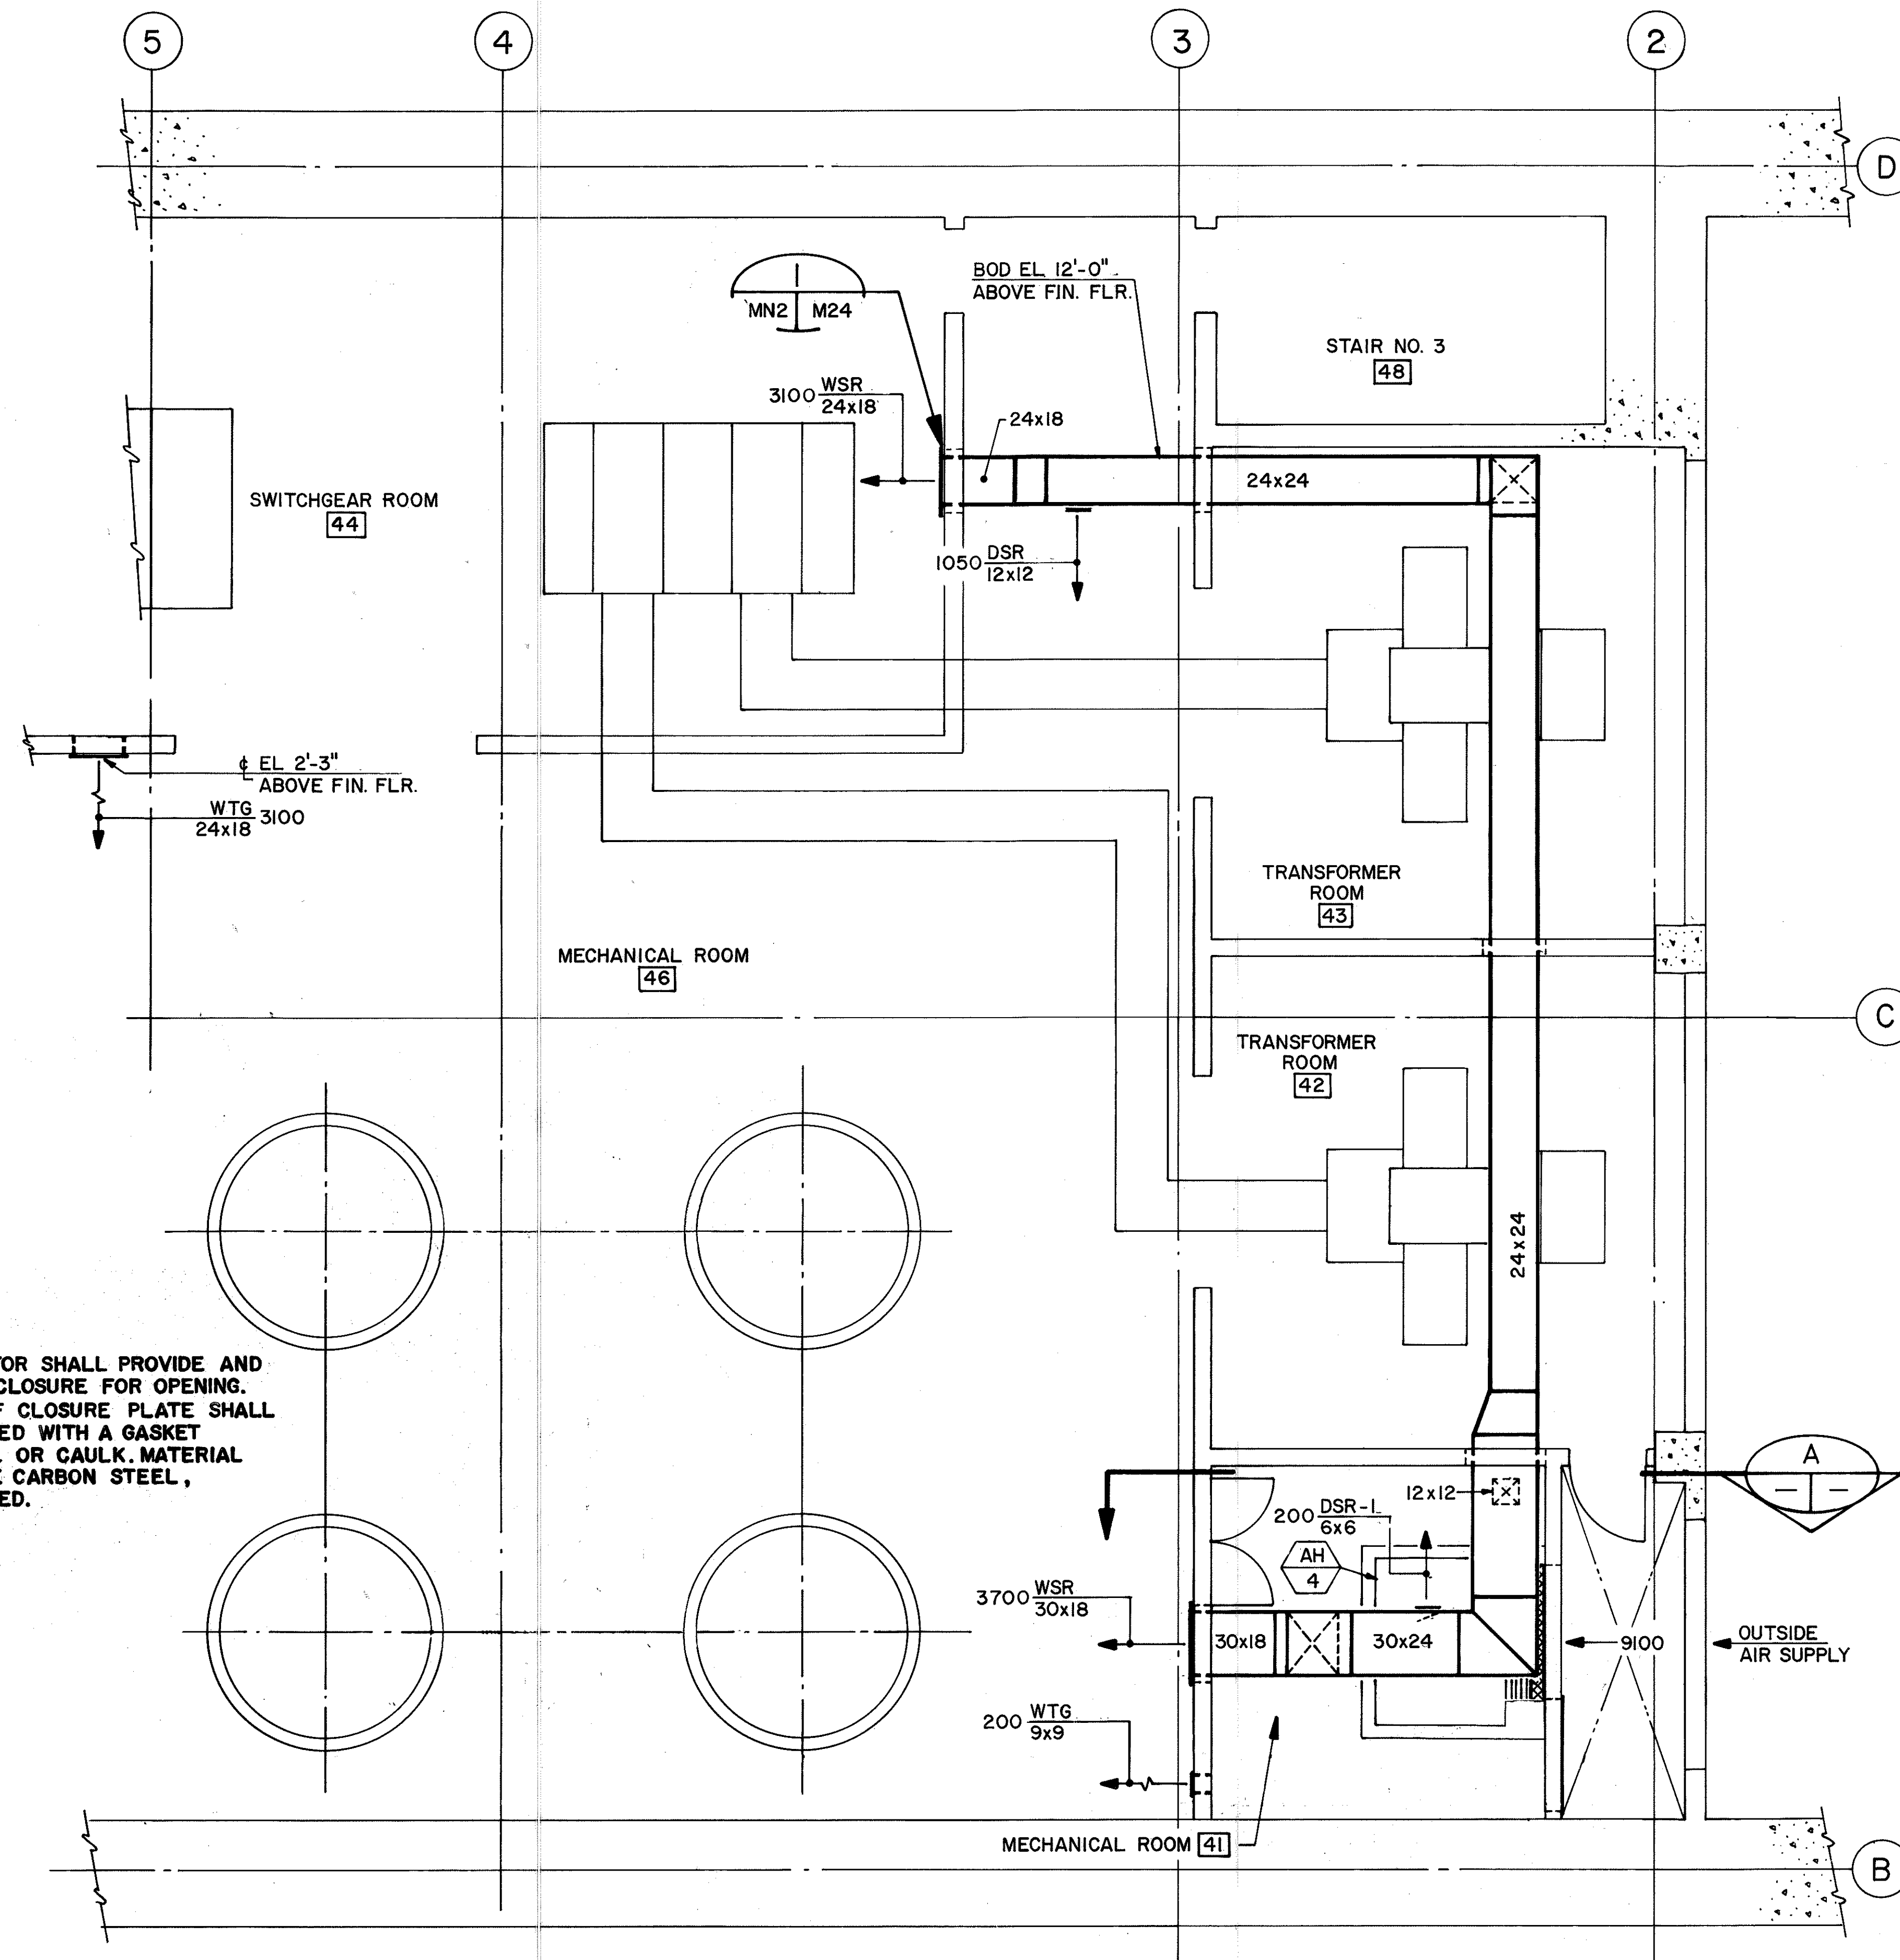

NOTE:
CONTRACTOR SHALL PROVIDE AND INSTALL CLOSURE FOR OPENING. EDGES OF CLOSURE PLATE SHALL BE SEALED WITH A GASKET MATERIAL OR CAULK. MATERIAL SHALL BE CARBON STEEL, GALVANIZED.

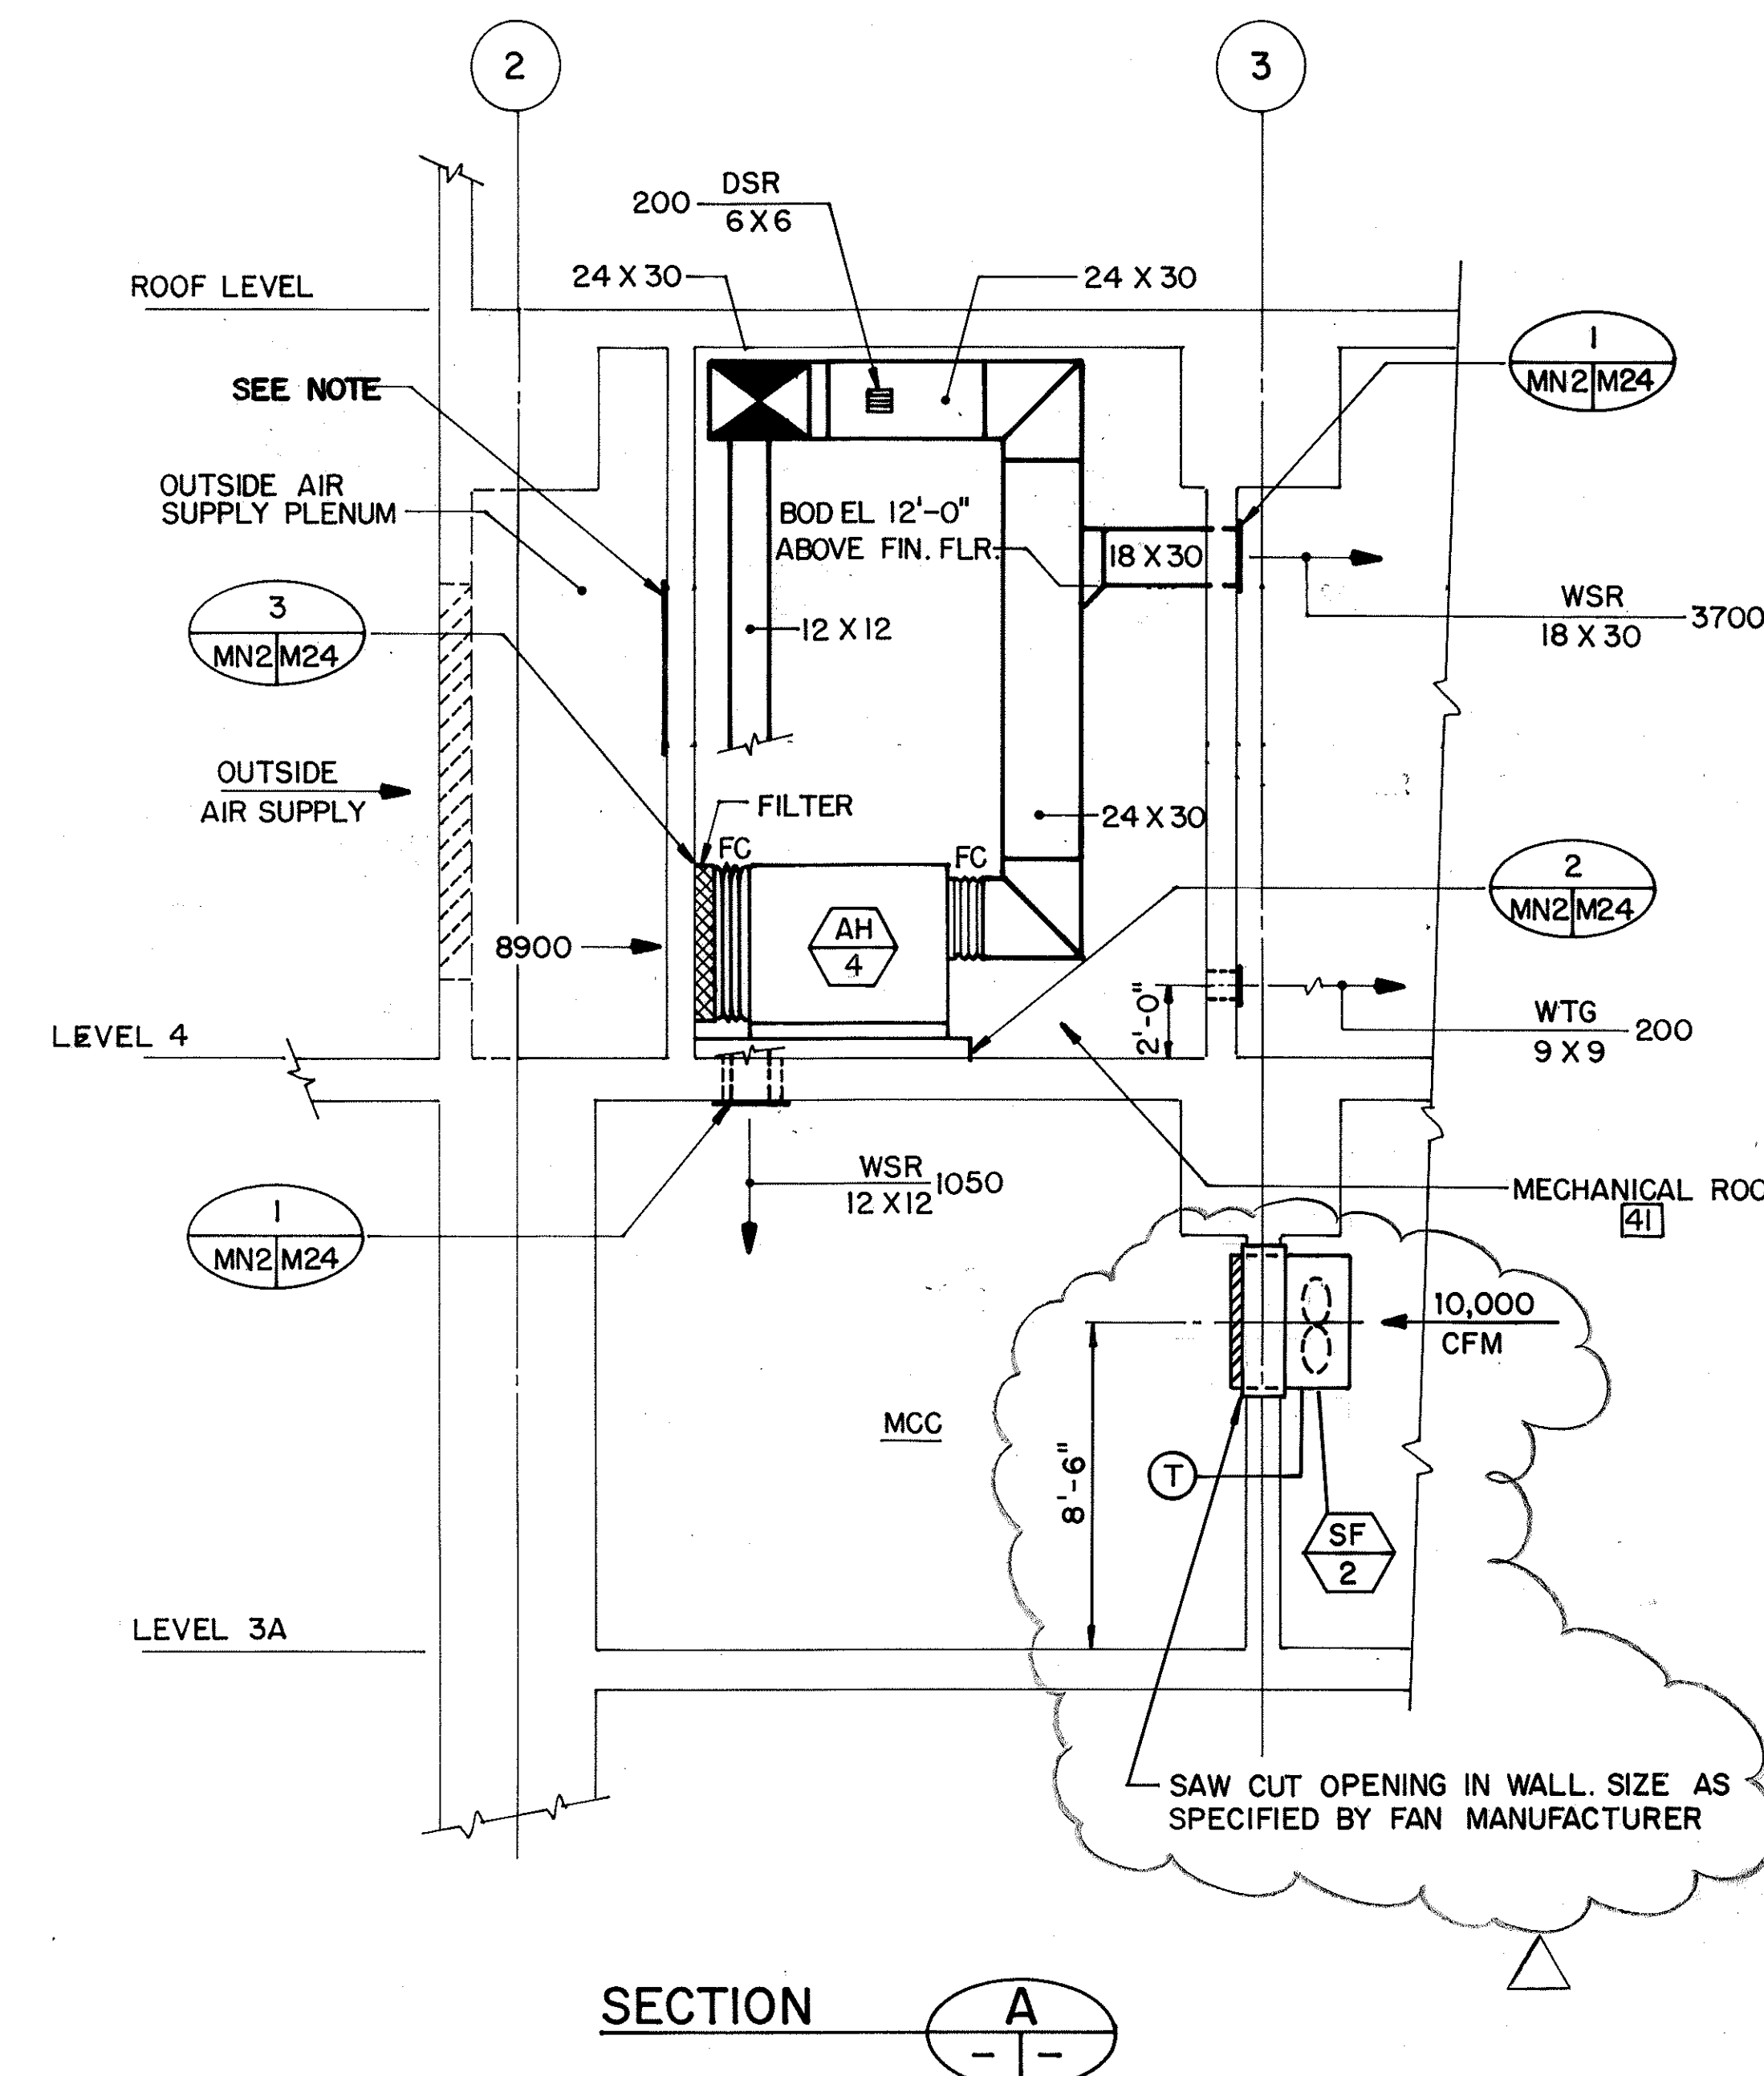

SECTION A-A

SURVEY PLOTTED BY	DATE
DRAWN BY	02/16/90
DESIGNED BY	07/17/90
QUANTITIES BY	06/07/90
CHECKED BY	
NO.	





THIS WORK WAS PREPARED BY ME OR UNDER MY SUPERVISION


John N. Que

DATE	REVISION
3/8/94	REV. SECT 'A', ADDED SF PER DCN 66-039
5/13/93	DELETED AUX. COOLING FANS & ASSOC DUCTWORK PER DCN 66-004
STATE OF HAWAII DEPARTMENT OF TRANSPORTATION HIGHWAYS DIVISION HVAC — LEVEL 4 PARTIAL PLAN AND SECTION HALAWA PORTAL BUILDING — 1B INTERSTATE ROUTE H-3 F.A.I. PROJ. NO. I-H3-1(66) SCALE: 1/4" = 1'-0" DATE: APR 1992 SHEET NO. MN2 OF 8 SHEETS	


FED. ROAD DIST. NO.	STATE	FED. AID PROJ. NO.	FISCAL YEAR	SHEET NO.	TOTAL SHEETS
HAWAII	HAW.	I-H3-1(66)	1992	43	440

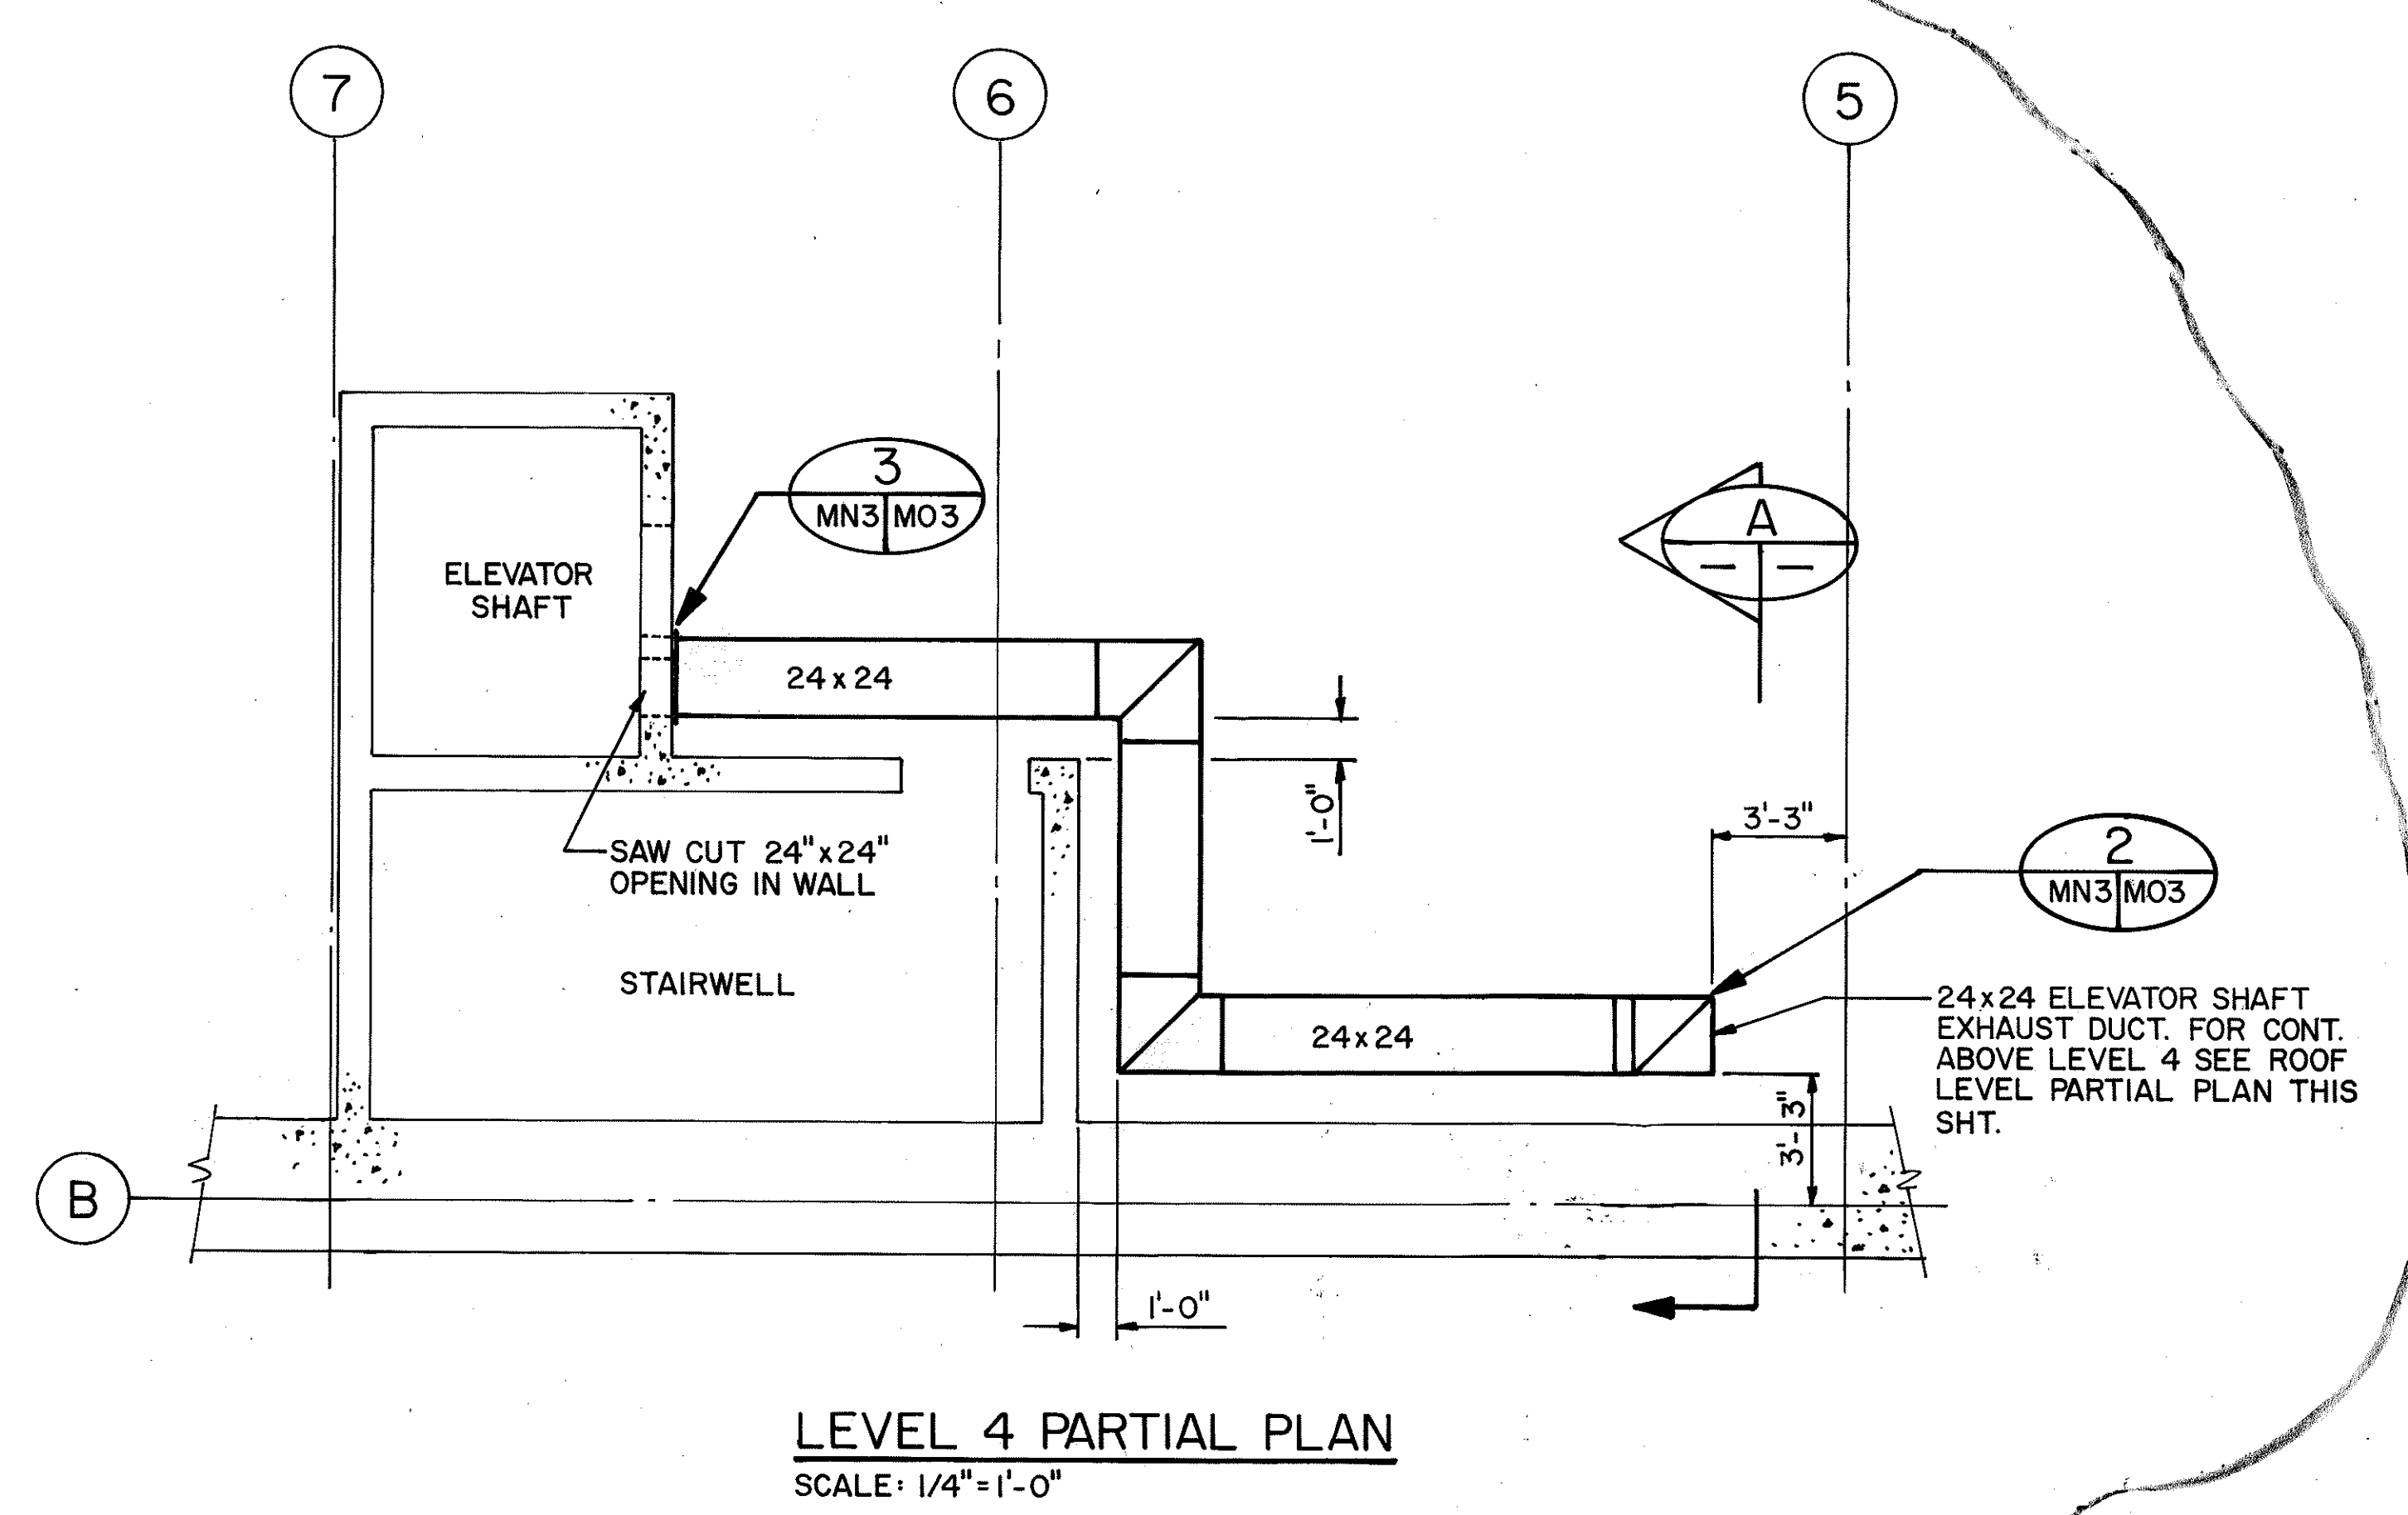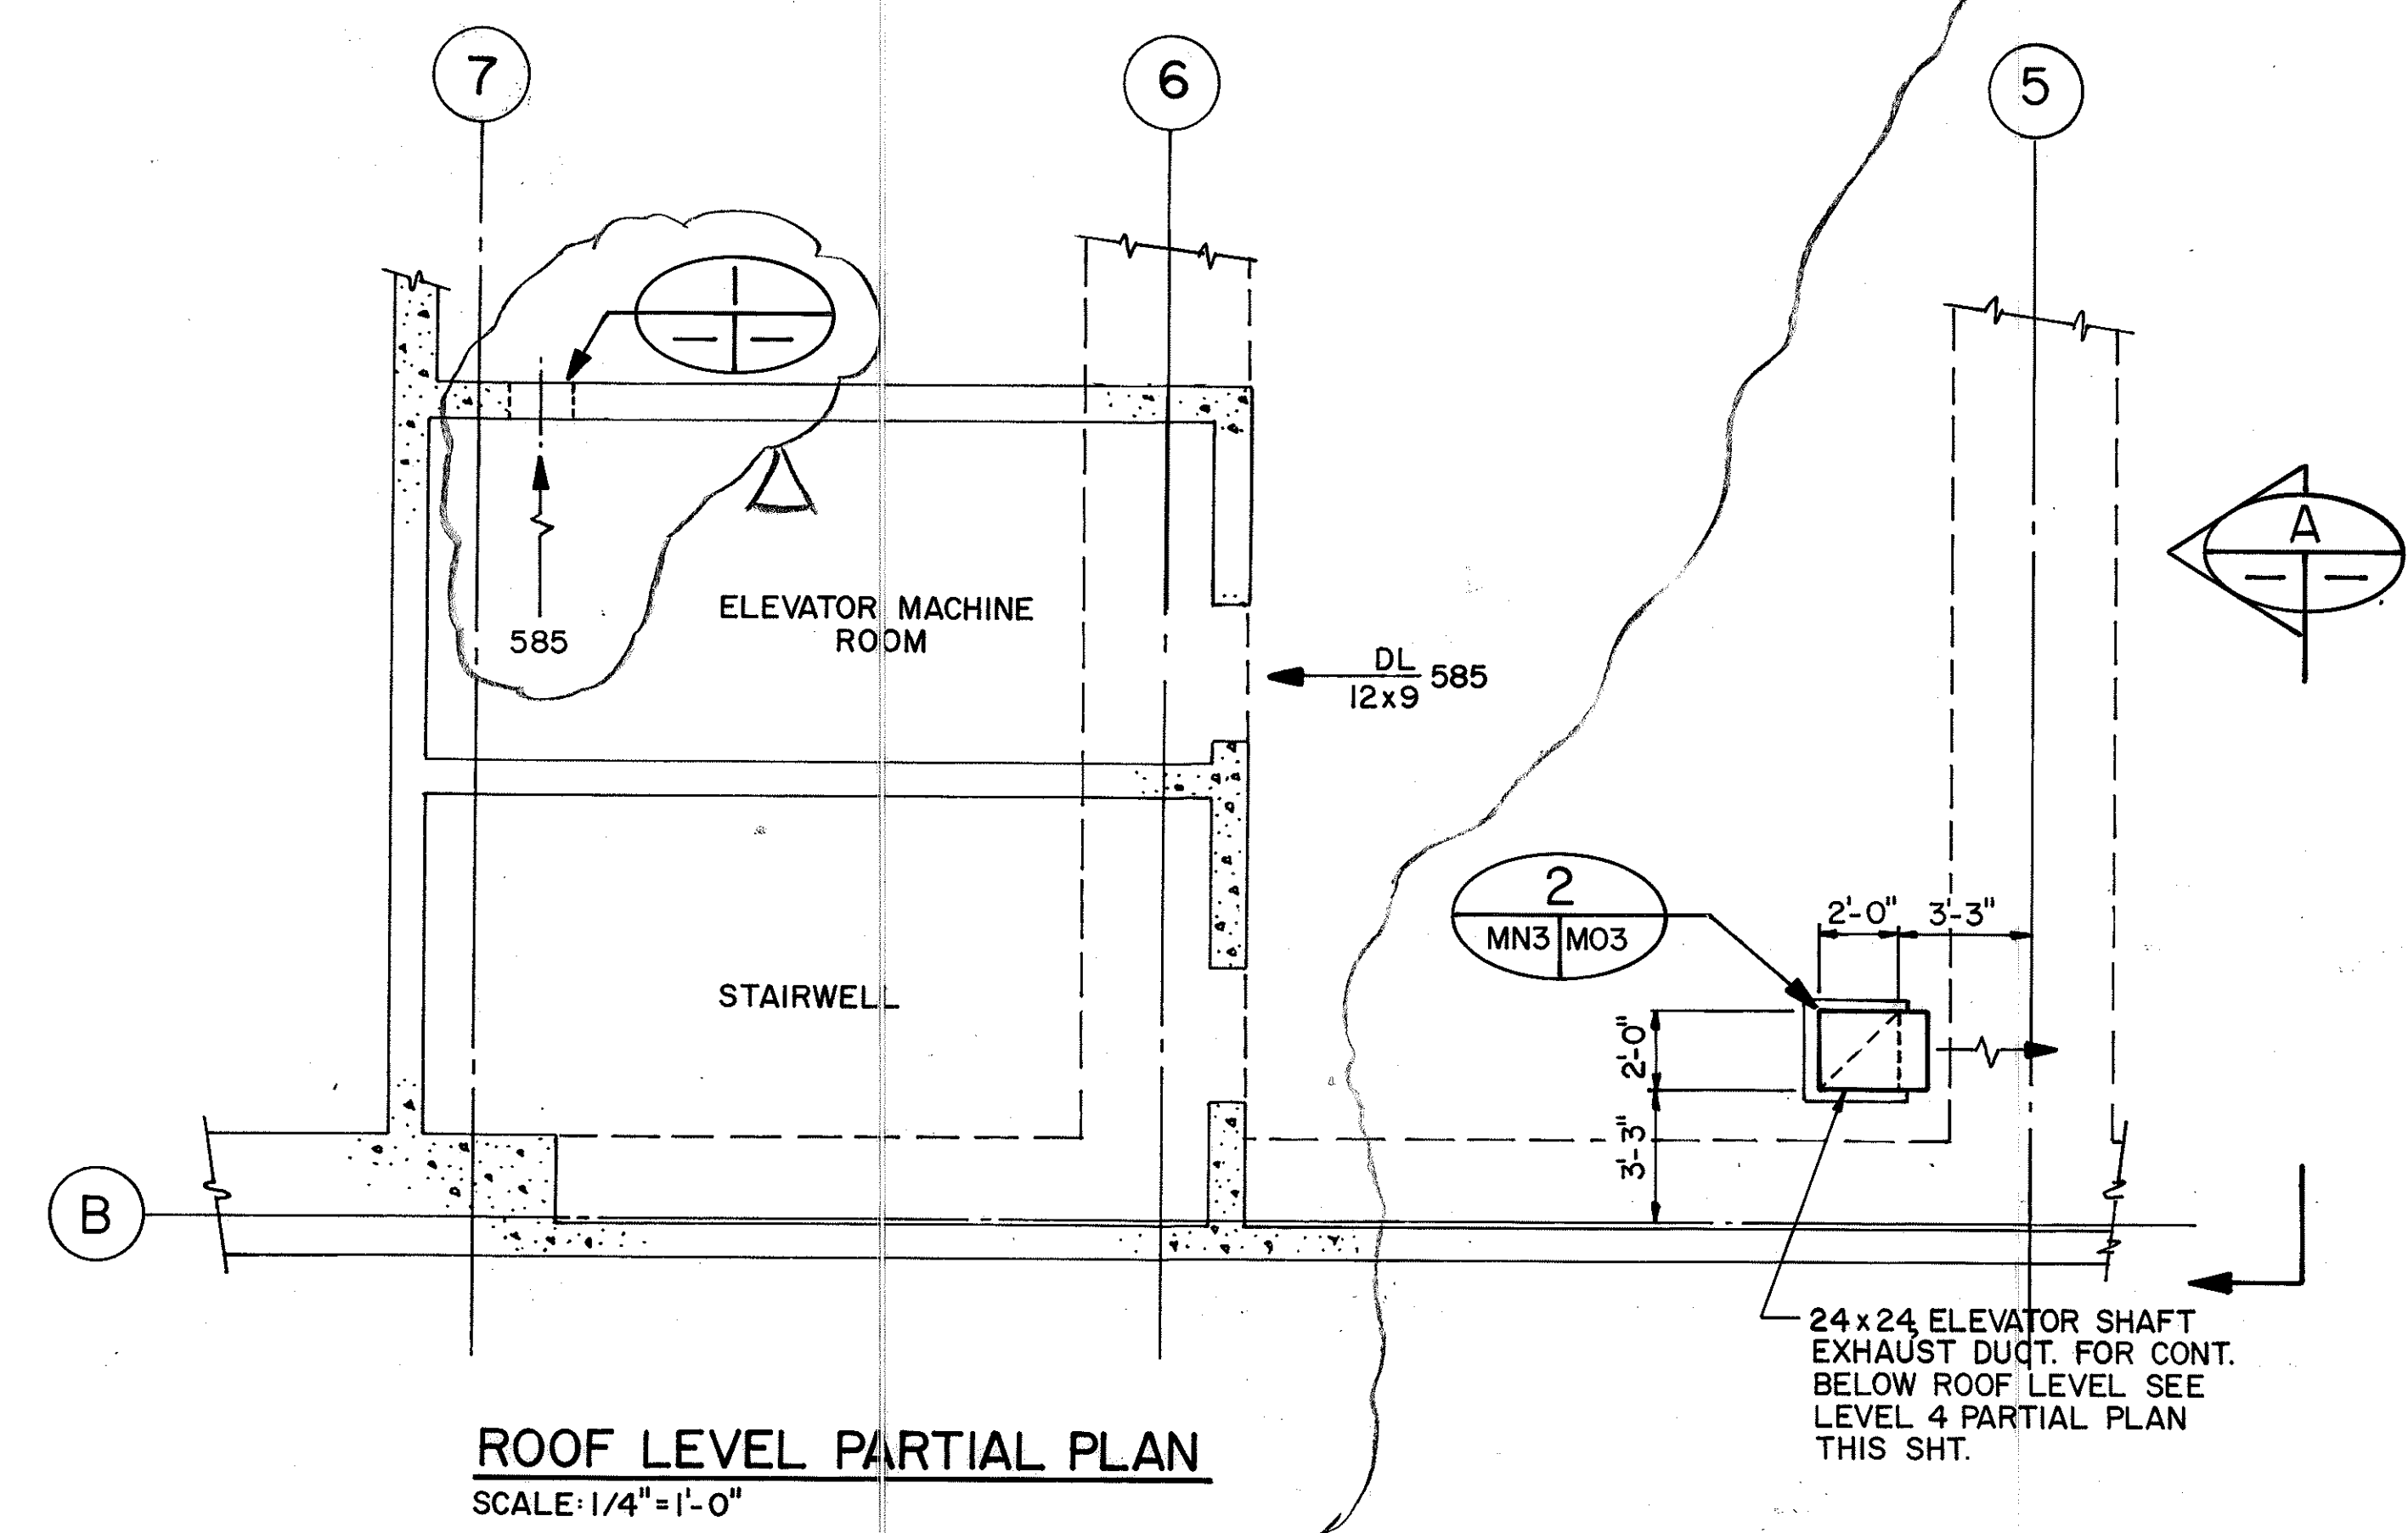

NOTE:
FOR SAW CUT OPENINGS-BUSH HAMMER EXPOSED EDGES TO EVEN SURFACE, GRIND SMOOTH. PAINT EDGES OF OPENINGS AND EXPOSED REBAR WITH EPOXY PAINT.

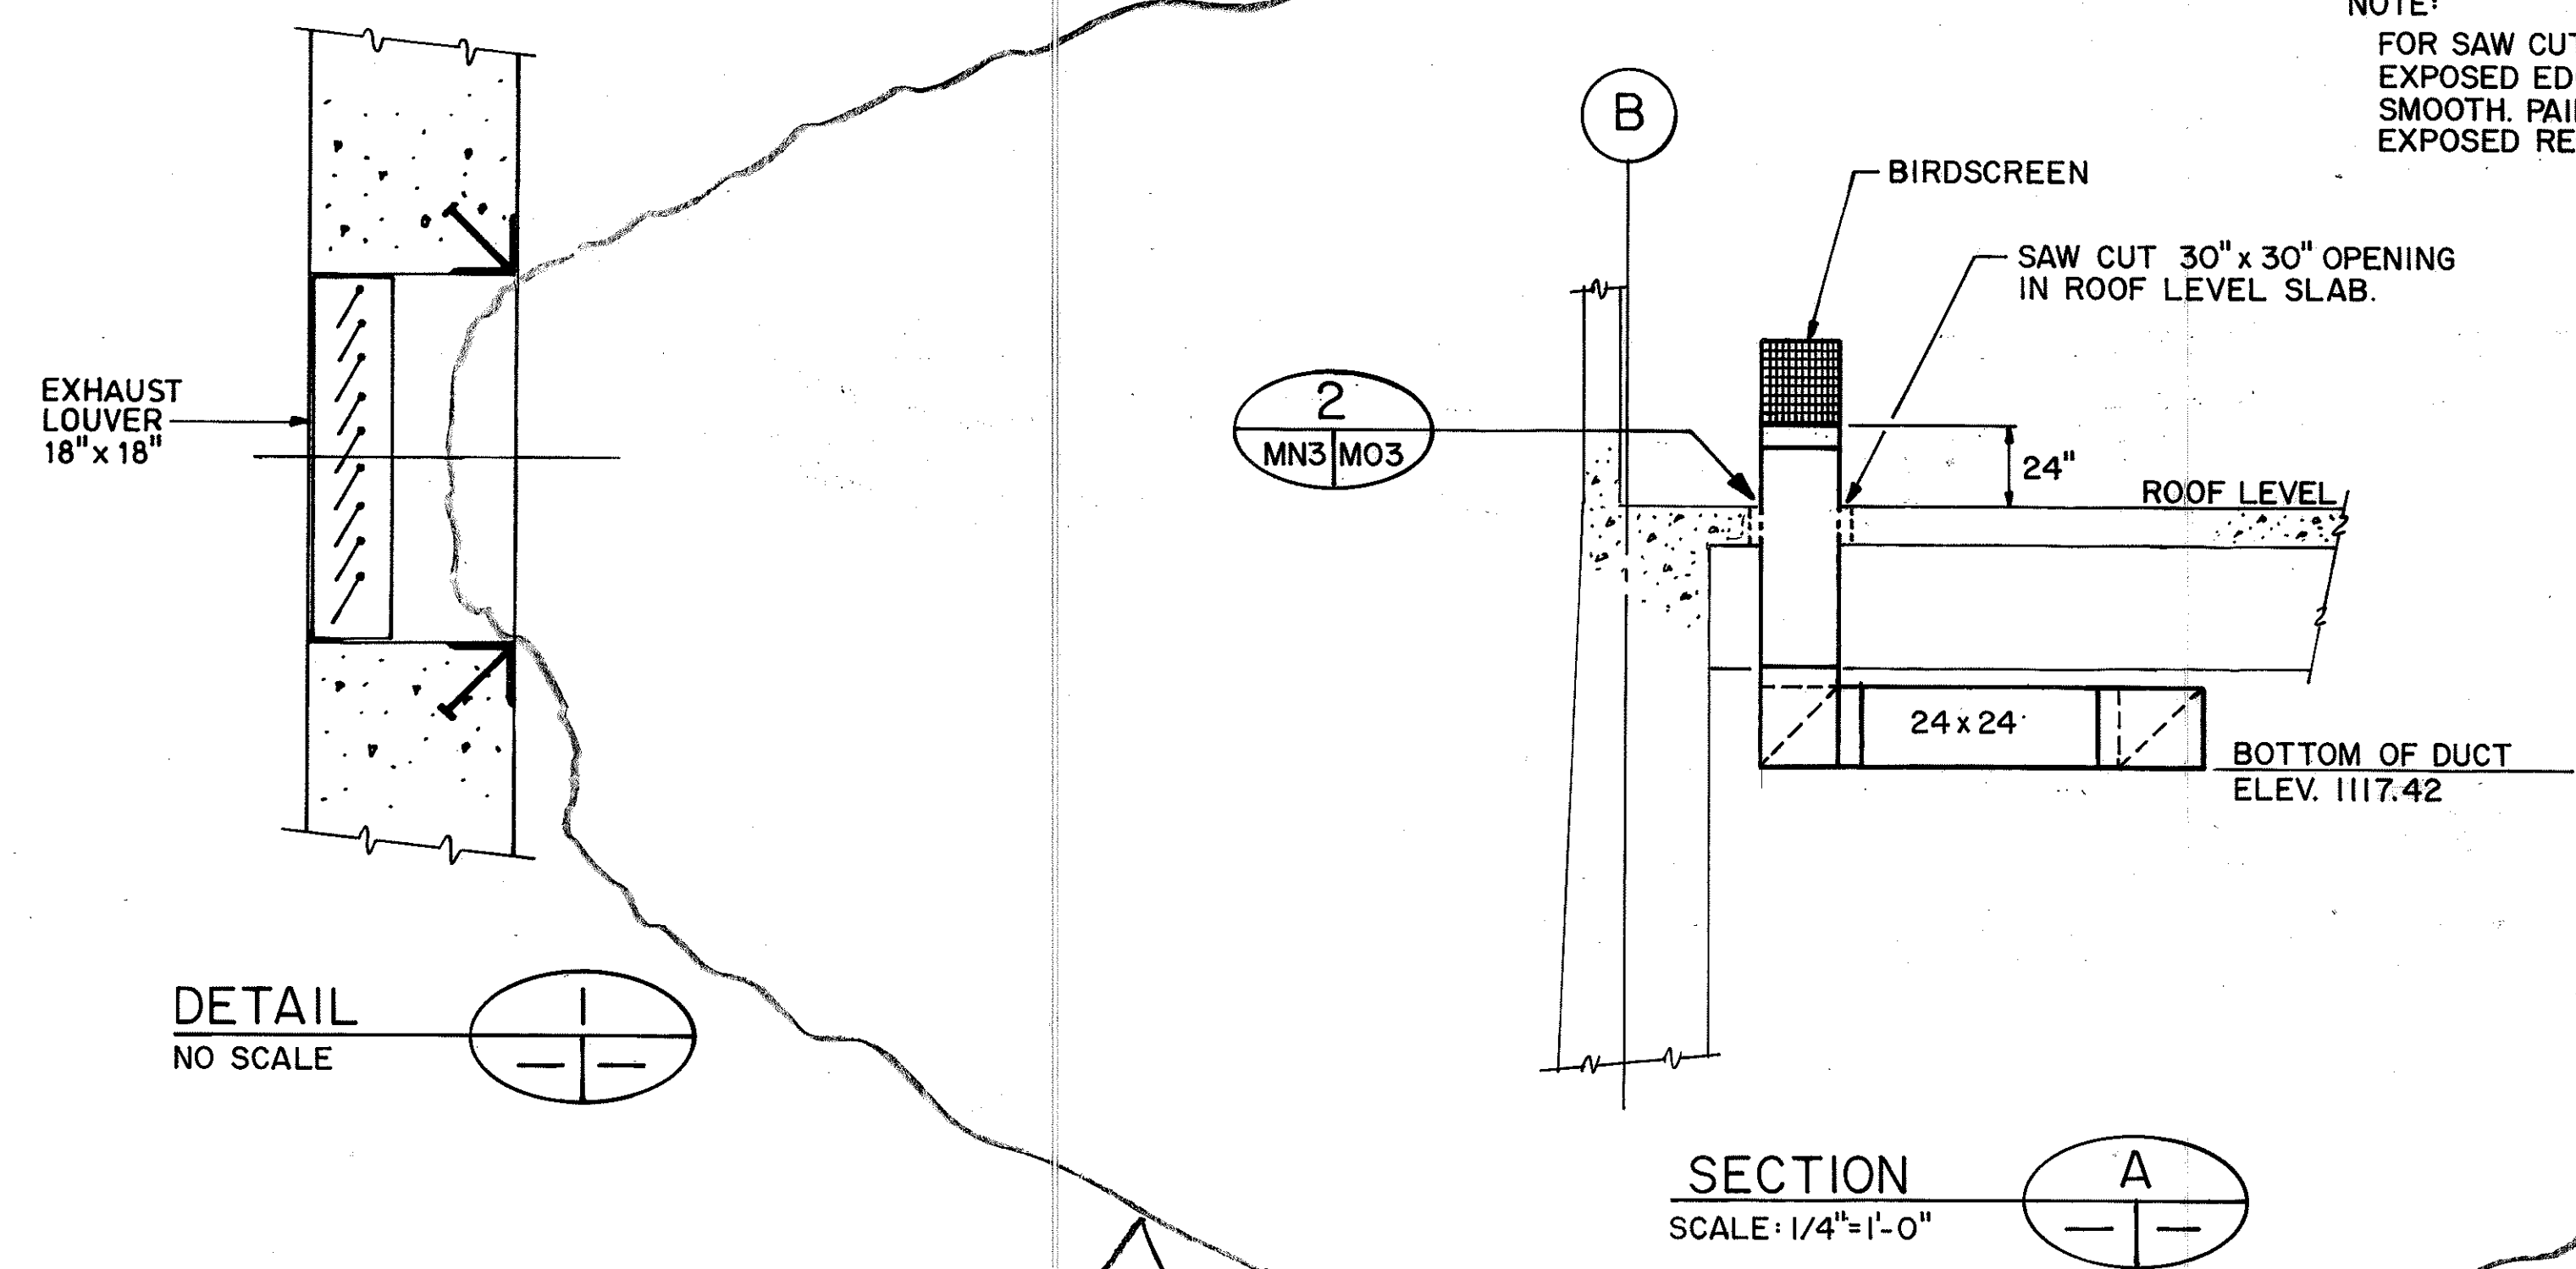

ORIGINAL PLANS	DATE
DESIGNED BY	12/14/89
DRAWN BY	D. E. DRYDEN
CHECKED BY	D. E. DRYDEN
NOTED BY	J. N. QUE
DATE	05/05/90

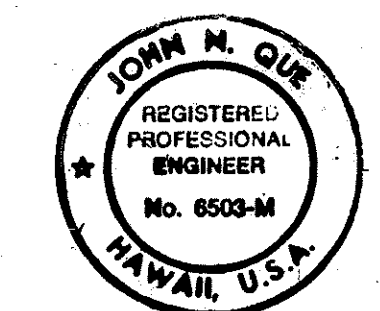

THIS WORK WAS PREPARED BY ME OR UNDER MY SUPERVISION

8/15/94	REV. PER DCN 66-052
DATE	REVISION

STATE OF HAWAII
DEPARTMENT OF TRANSPORTATION
HIGHWAYS DIVISION

HVAC-ELEVATOR EQUIPMENT ROOM PLAN AND DETAILS


HALAWA PORTAL BUILDING - 1B

INTERSTATE ROUTE H-3
F.A.I. PROJ. NO. I-H3-1 (66)


SCALE: AS NOTED DATE: APR 1992

SHEET NO. MN3 OF 8 SHEETS


FED. ROAD DIST. NO.	STATE	FED. AID PROJ. NO.	FISCAL YEAR	SHEET NO.	TOTAL SHEETS
HAWAII	HAW.	I - H3 - I (66)	1992	44	440

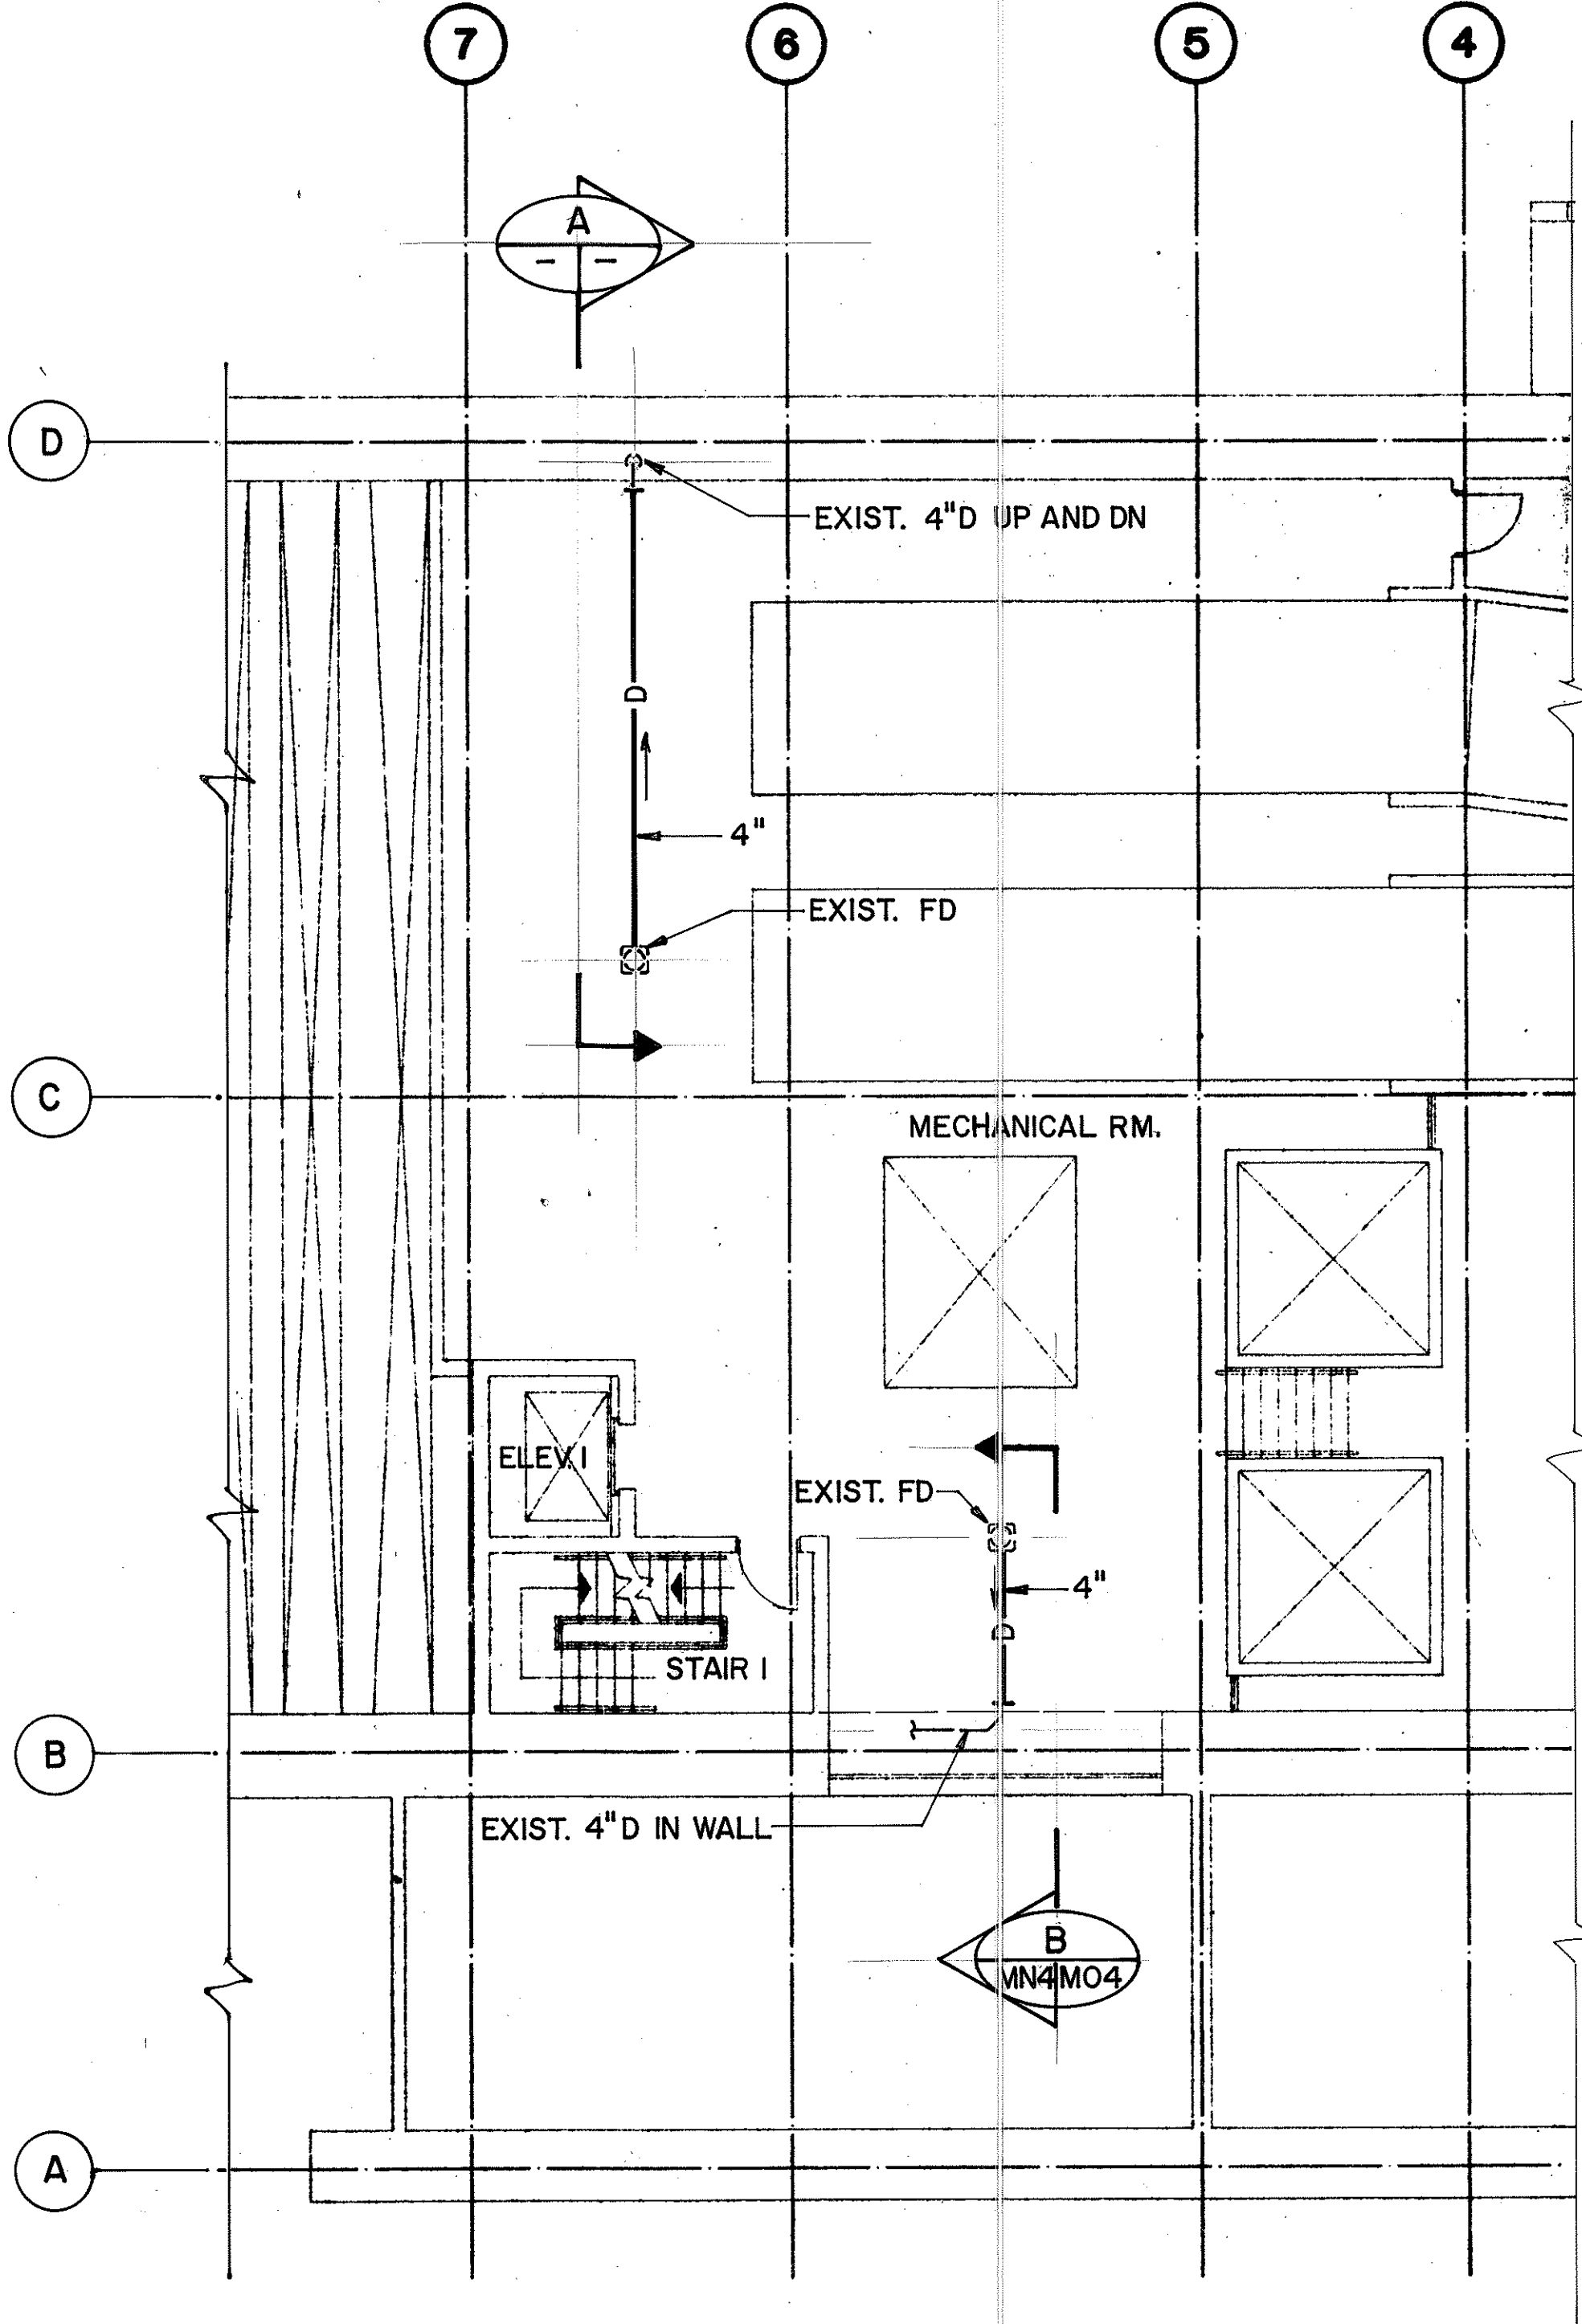

LEVEL 3 PARTIAL PLAN
SCALE: 1/8" = 1'-0"

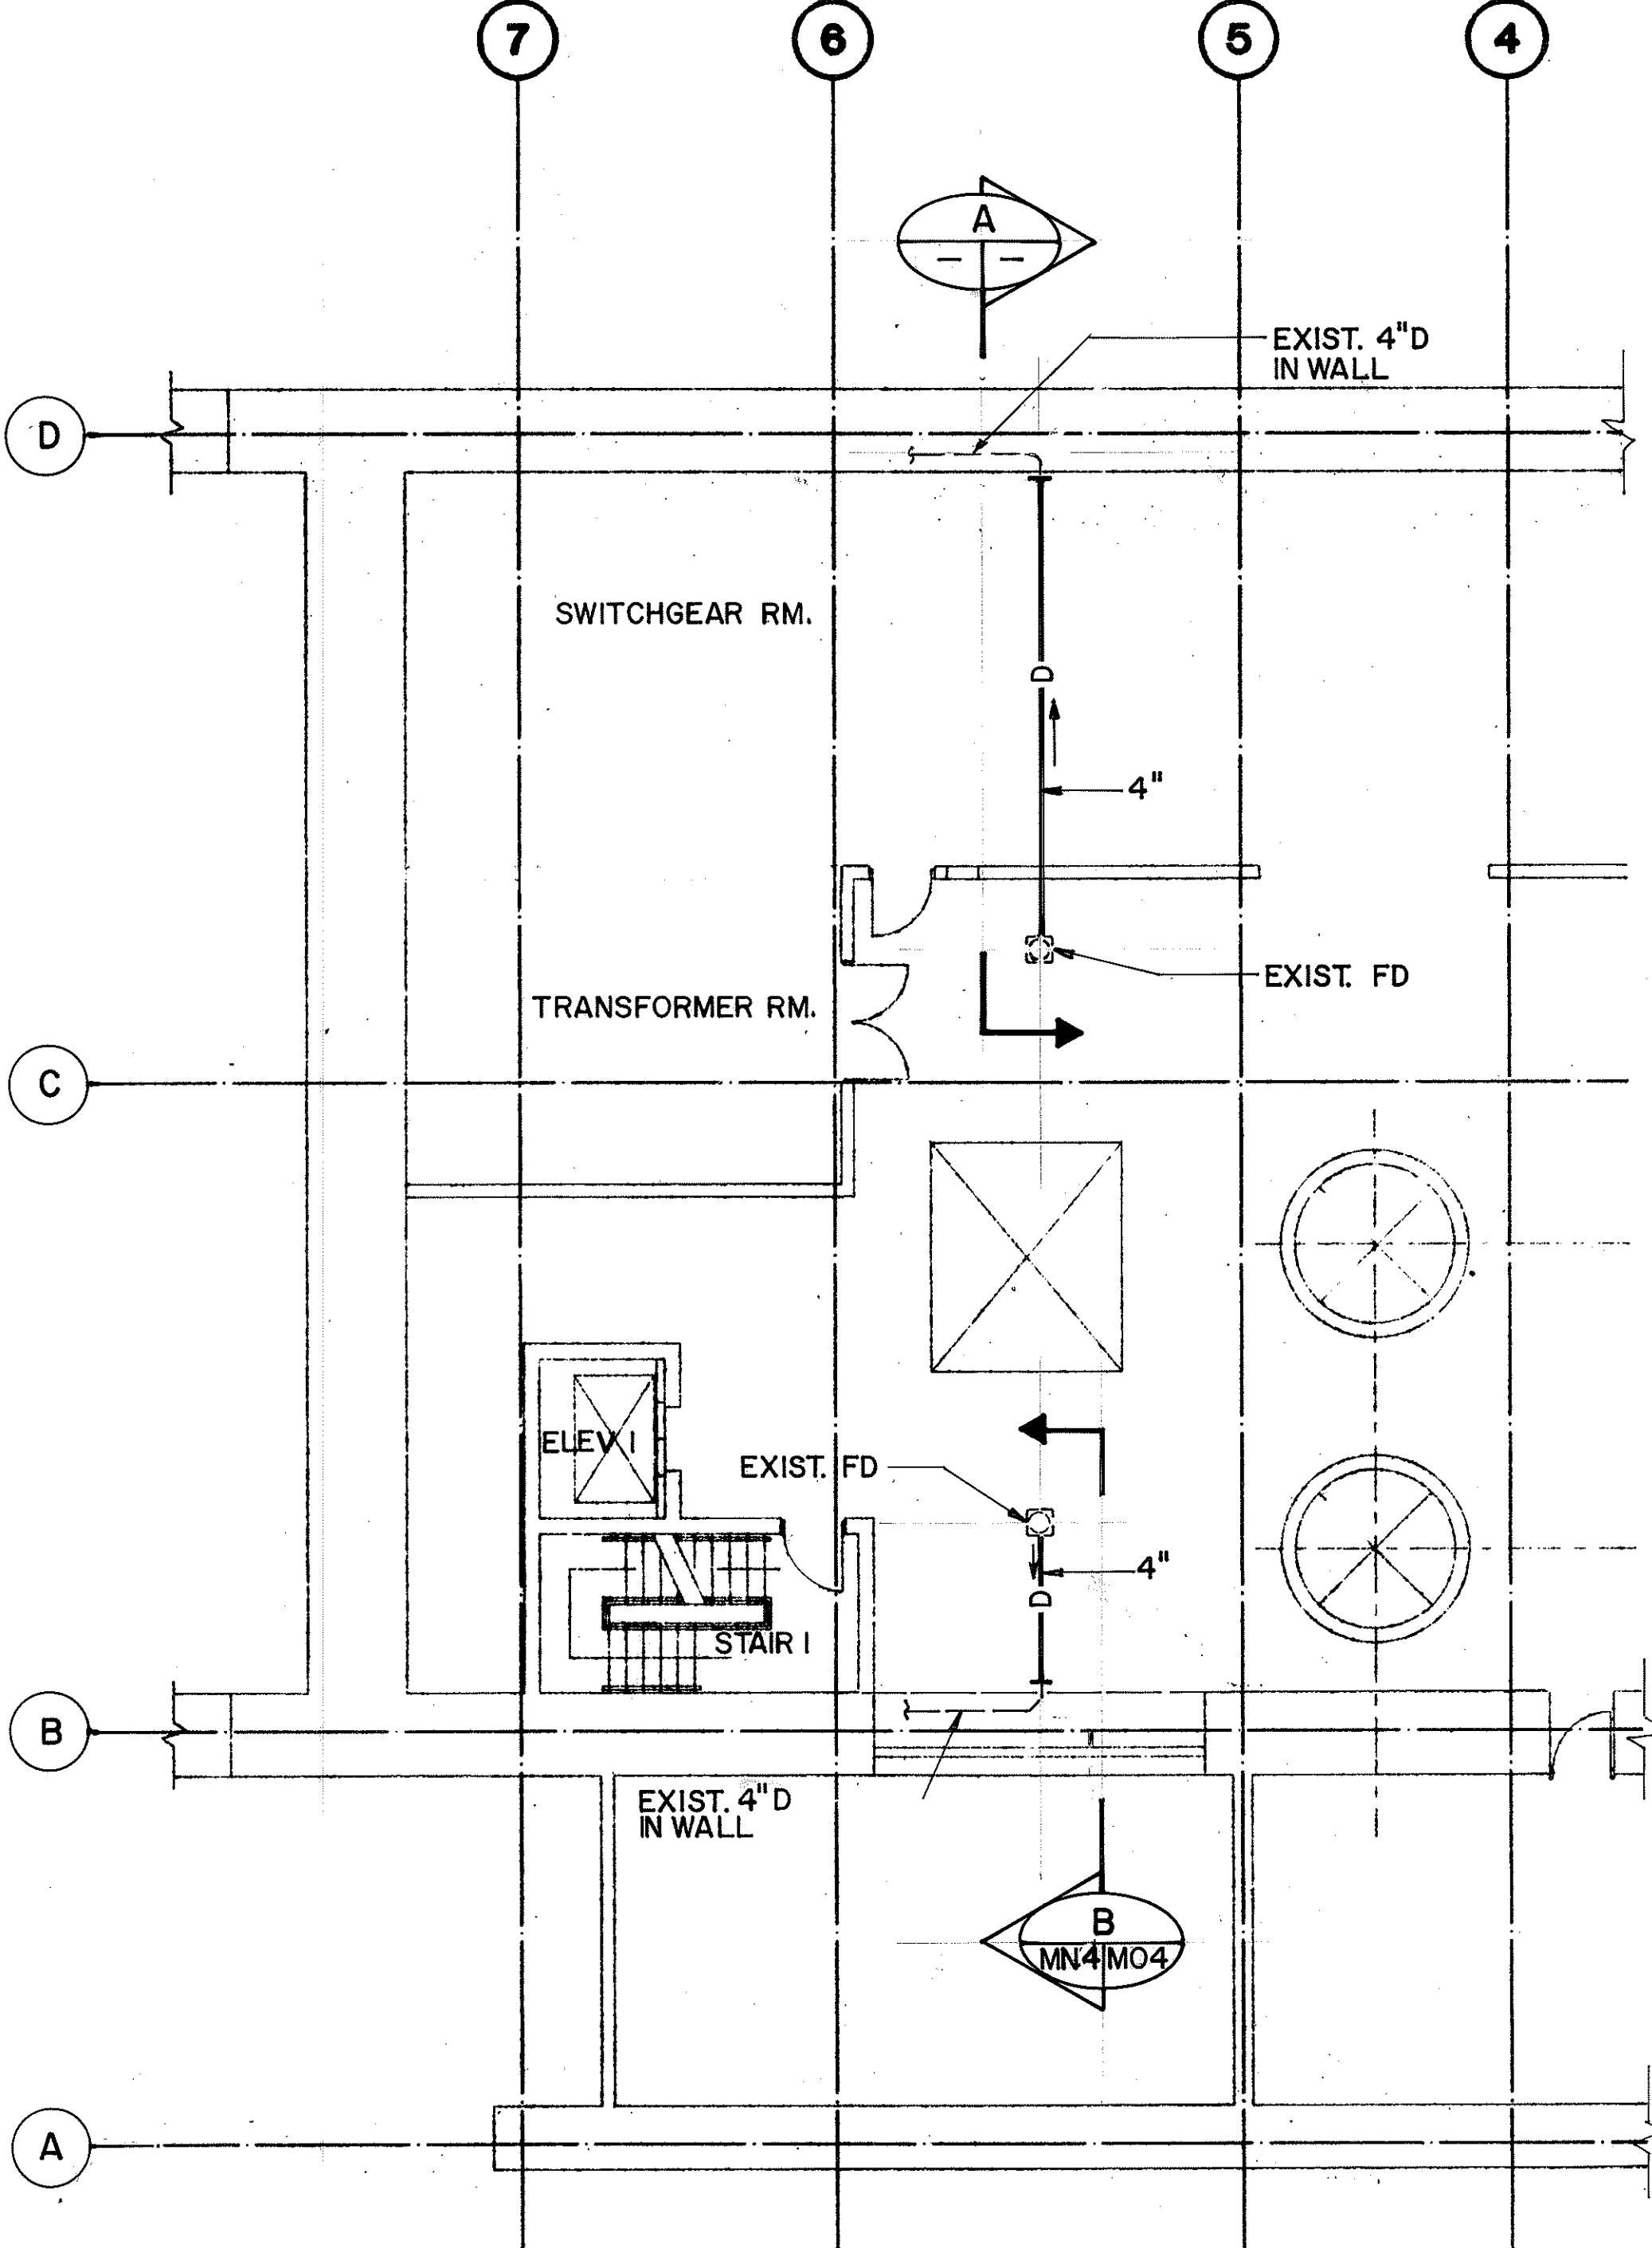

LEVEL 4 PARTIAL PLAN
SCALE: 1/8" = 1'-0"

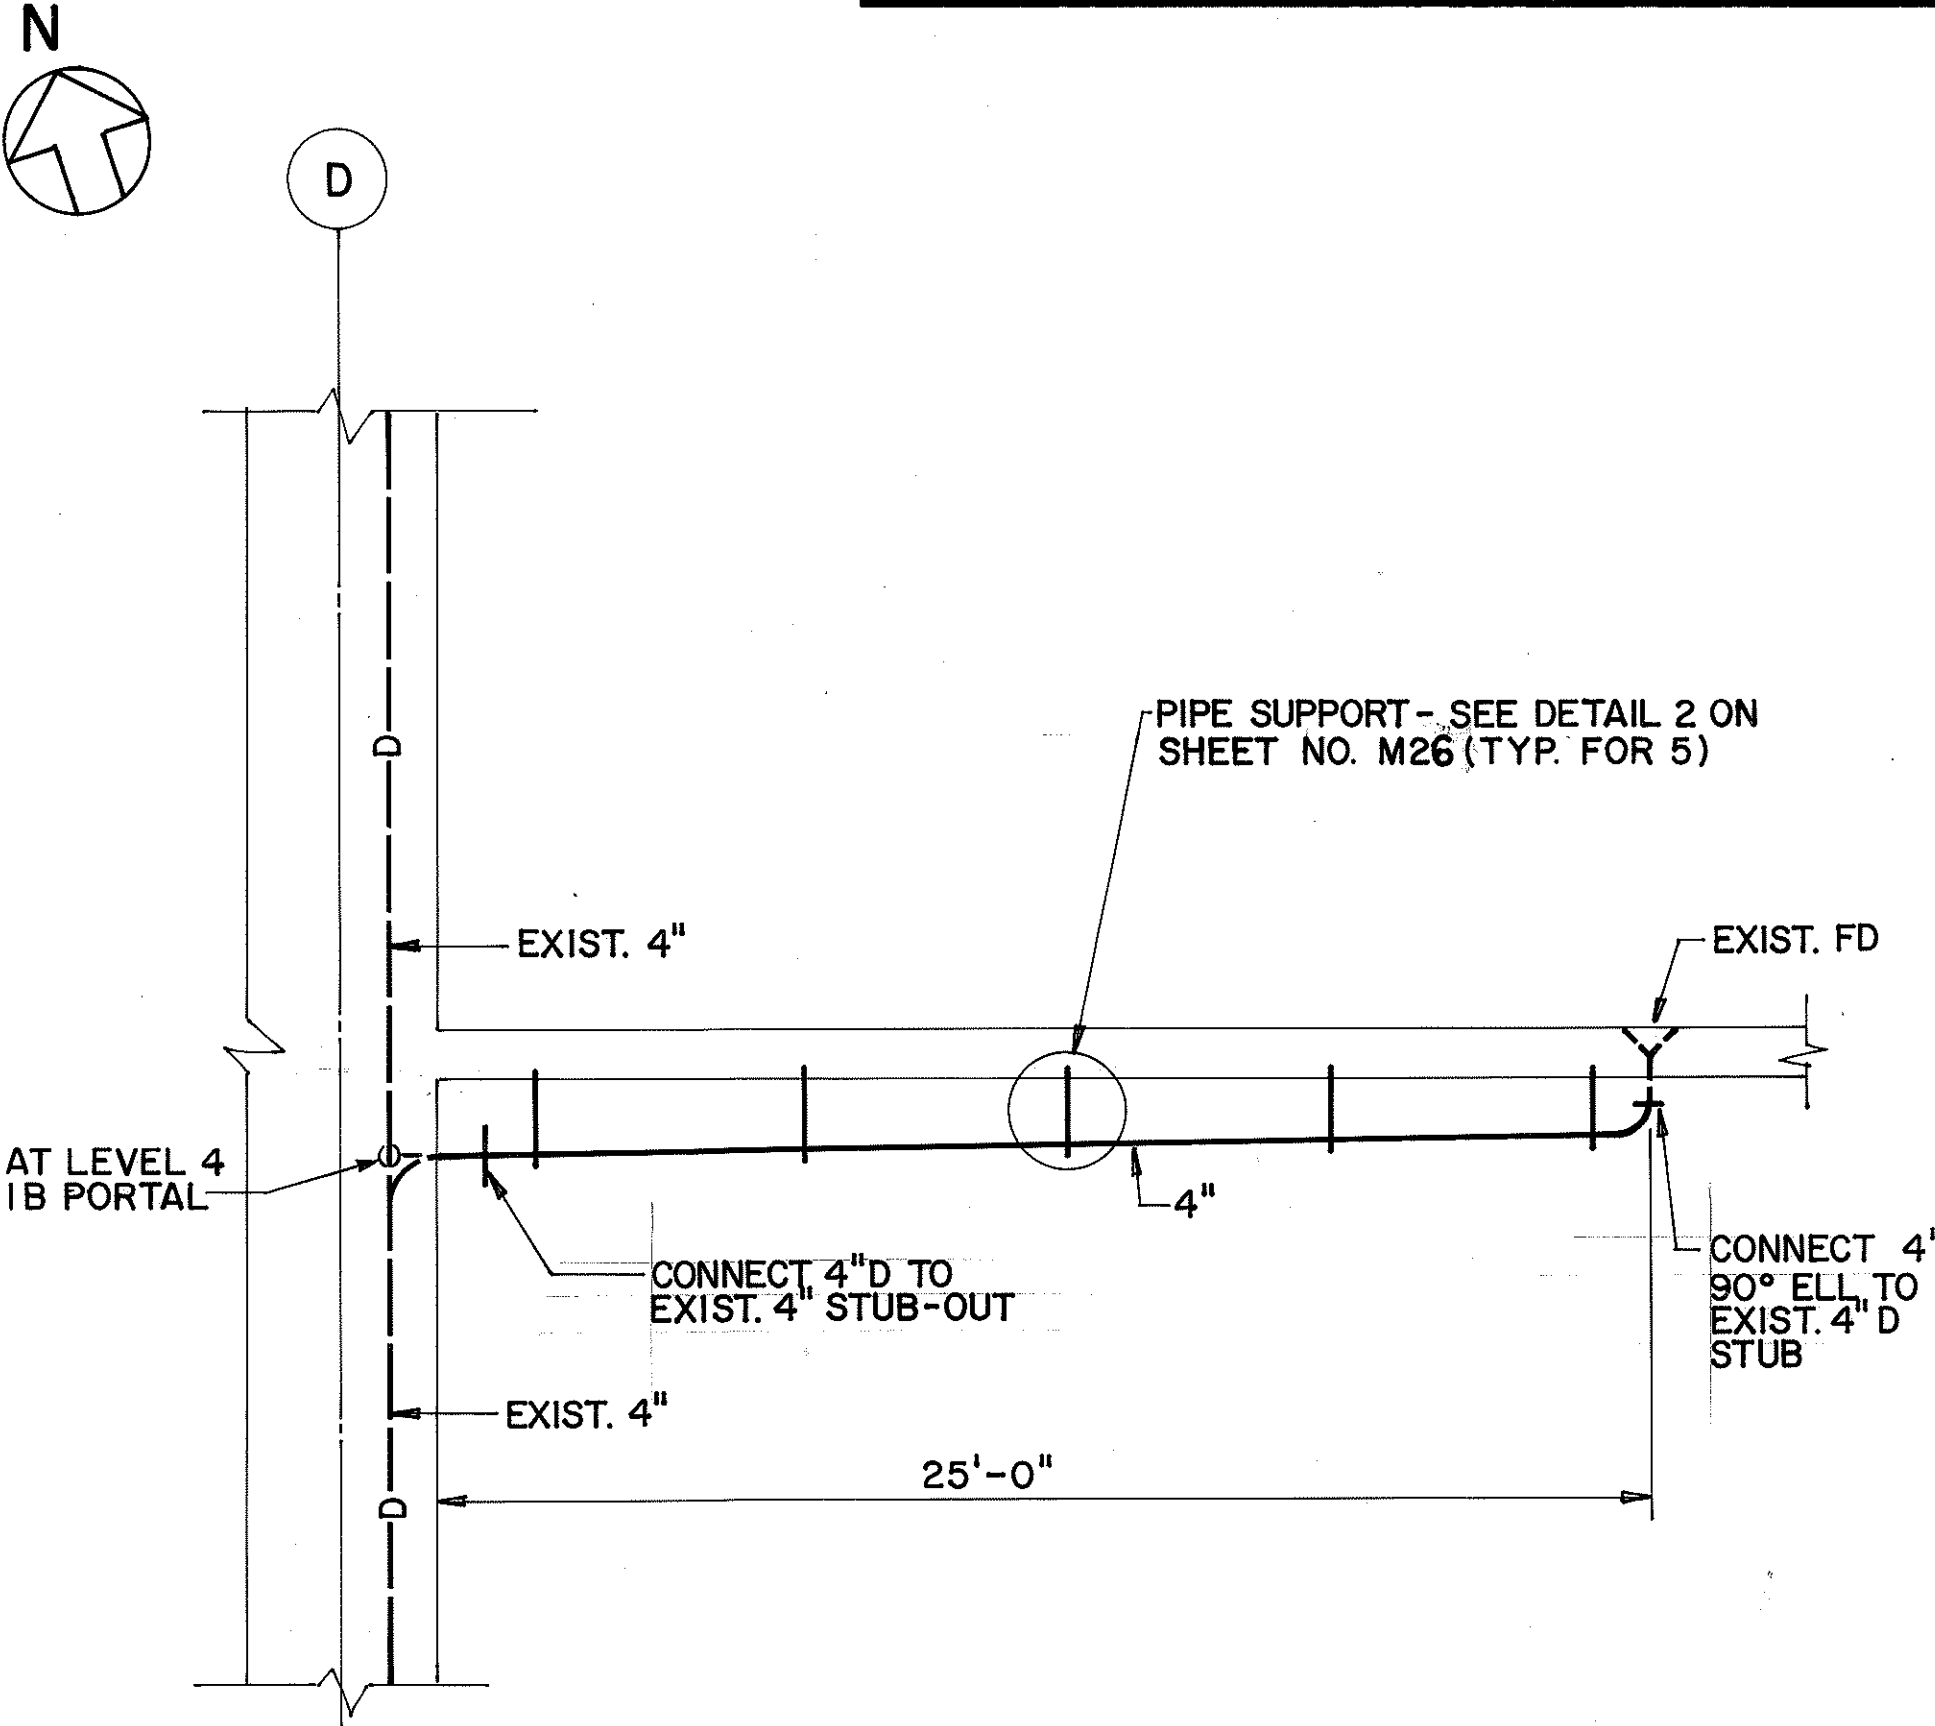

SECTION
SCALE: 1/4" = 1'-0"

A

MN 4
MO 4

MN 4

**FOR DETAIL AS-BUILT INFORMATION
REFER TO CONSTRUCTION SUBMITTALS**

[illegible]

DATE	REVISION

STATE OF HAWAII
DEPARTMENT OF TRANSPORTATION
HIGHWAYS DIVISION

**PLUMBING - LEVEL 3 &
LEVEL 4 PARTIAL PLANS**
HALAWA PORTAL BUILDING - IB

INTERSTATE ROUTE H-3
F.A.I. PROJ. NO. I-H3-1 (66)

SCALE : AS NOTED DATE : APR 1992

SHEET NO. MN4 OF 8 SHEETS

44

ORIGINAL PLAN	SURVEY PLOTTED BY B. BUNYI	DATE 01/16/90
NOTE: BOOK	DRAWN BY	
	DESIGNED BY P. L. LALOUE	01/06/90
	QUANTITIES BY	
	CHECKED BY J. N. QUE	06/04/90

GRAPHIC SCALES


4' 0' 4' 8'

$$1/4'' = 1' - 0''$$


8' 0' 8' 1'

$$1/8'' = 1'-0''$$


FED. ROAD DIST. NO.	STATE	FED. AID PROJ. NO.	FISCAL YEAR	SHEET NO.	TOTAL SHEETS
HAWAII	HAW.	I-H3-1(66)	1992	45	440

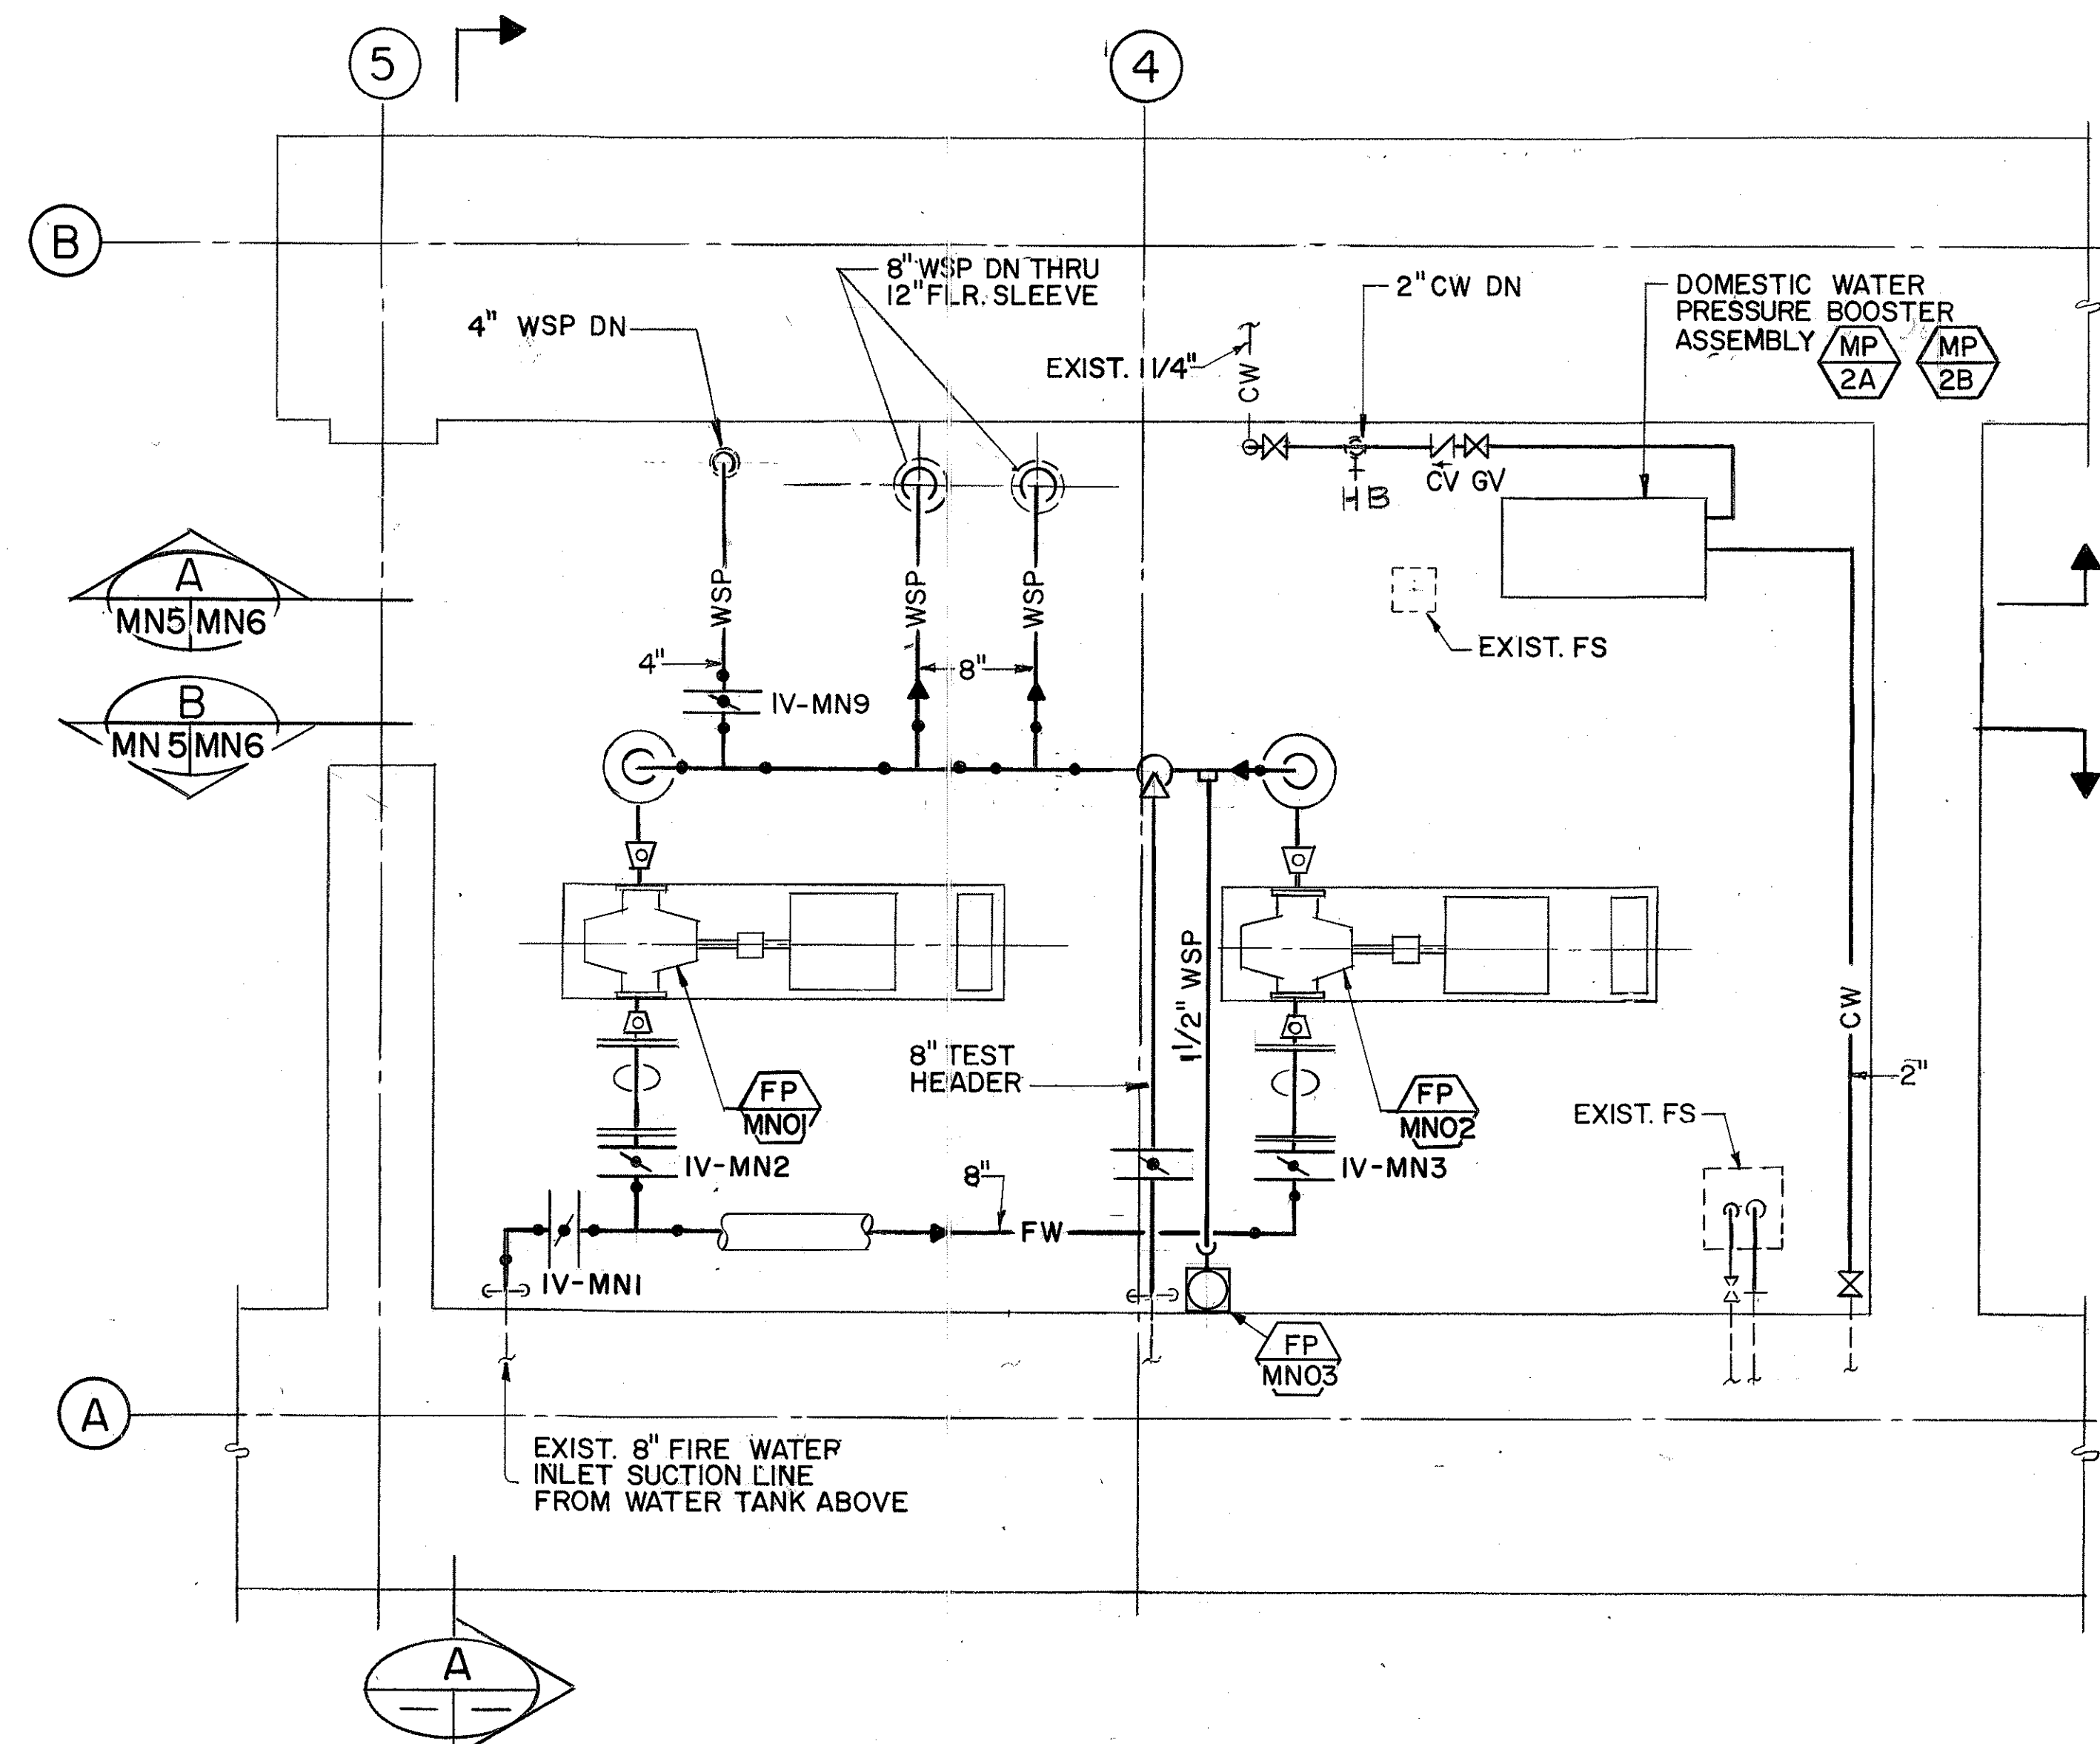

PUMP ROOM PARTIAL PLAN


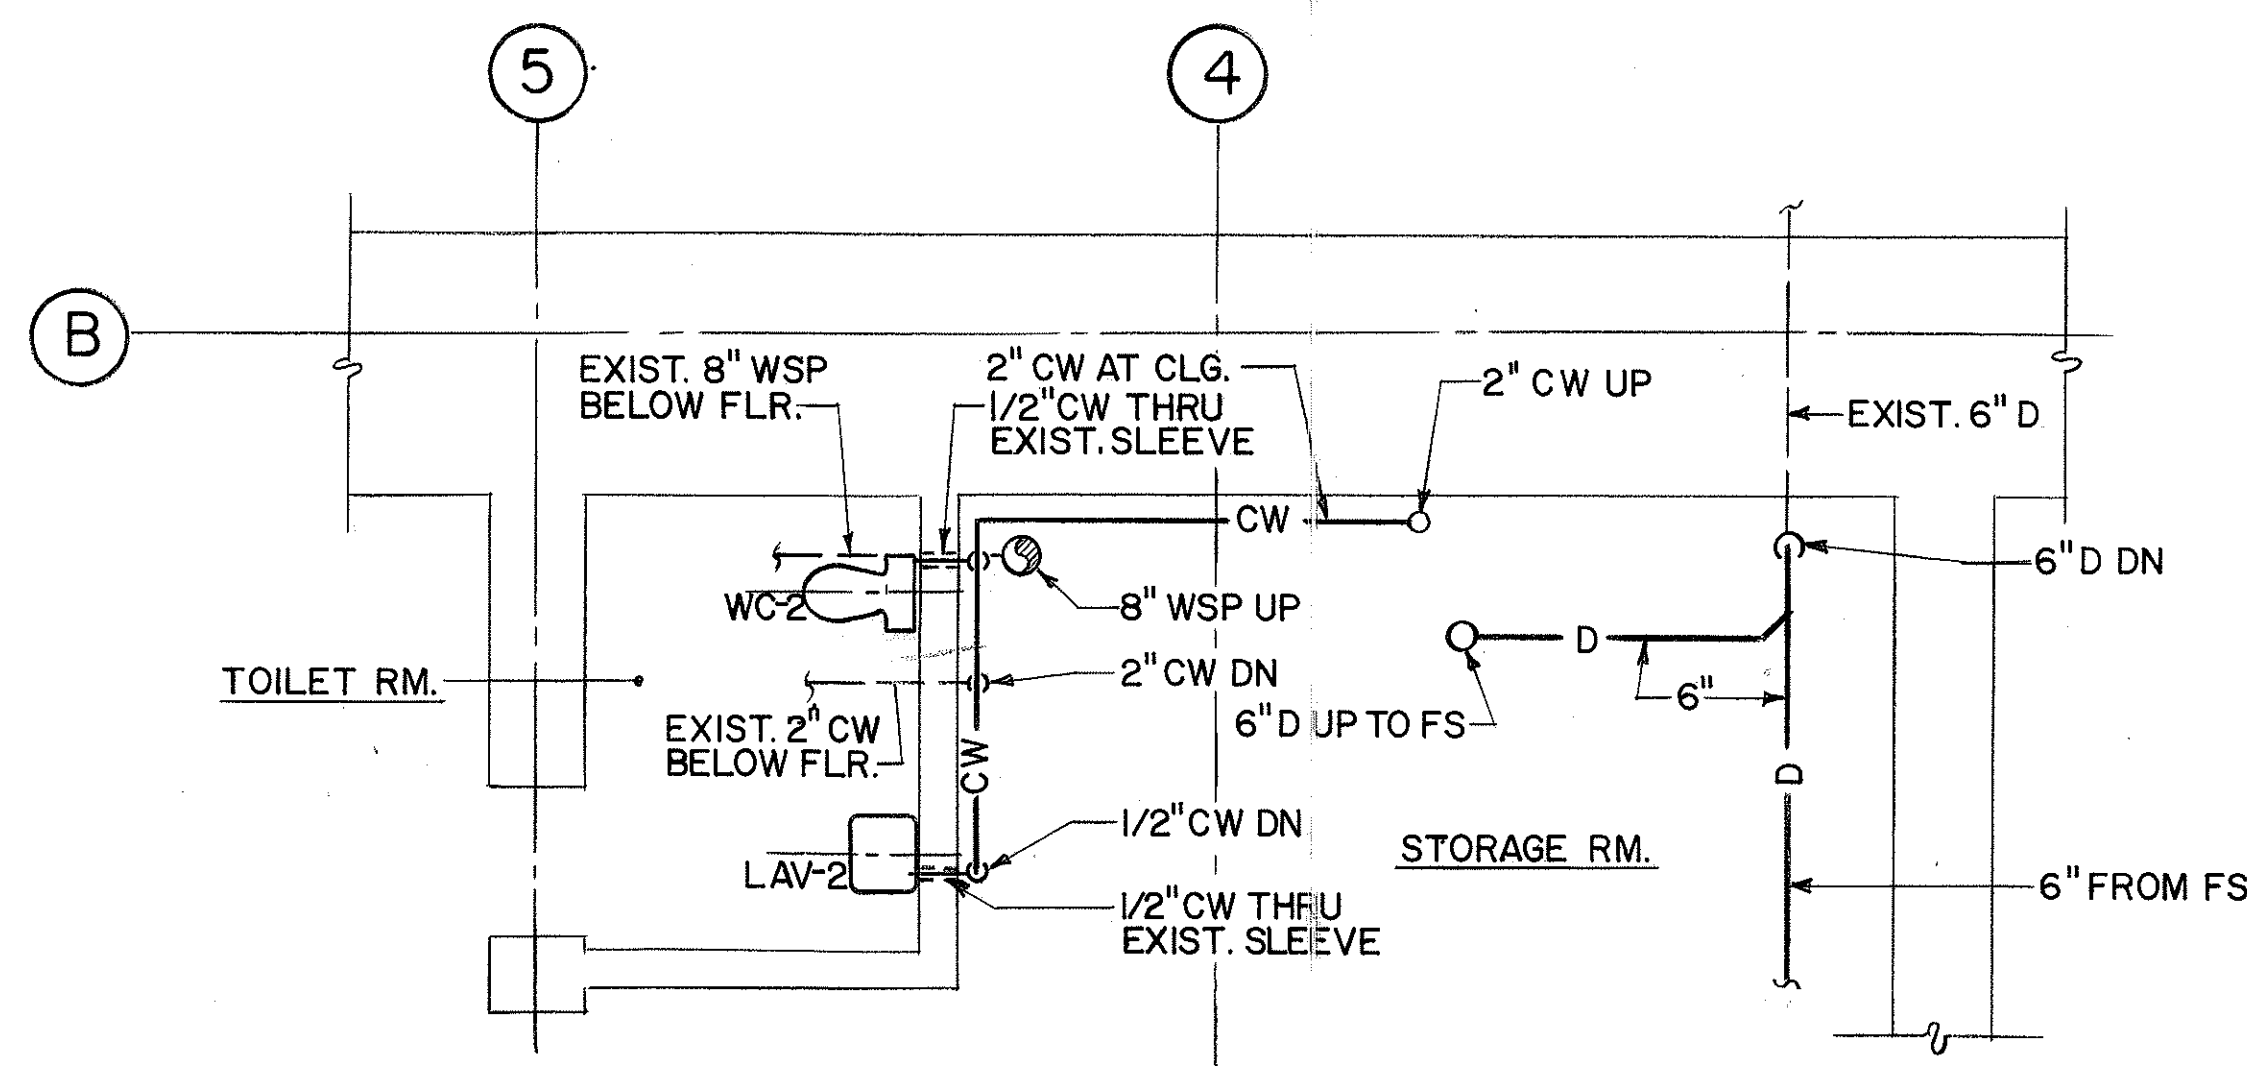


PARTIAL PLAN AT LOADING DOCK LEVEL

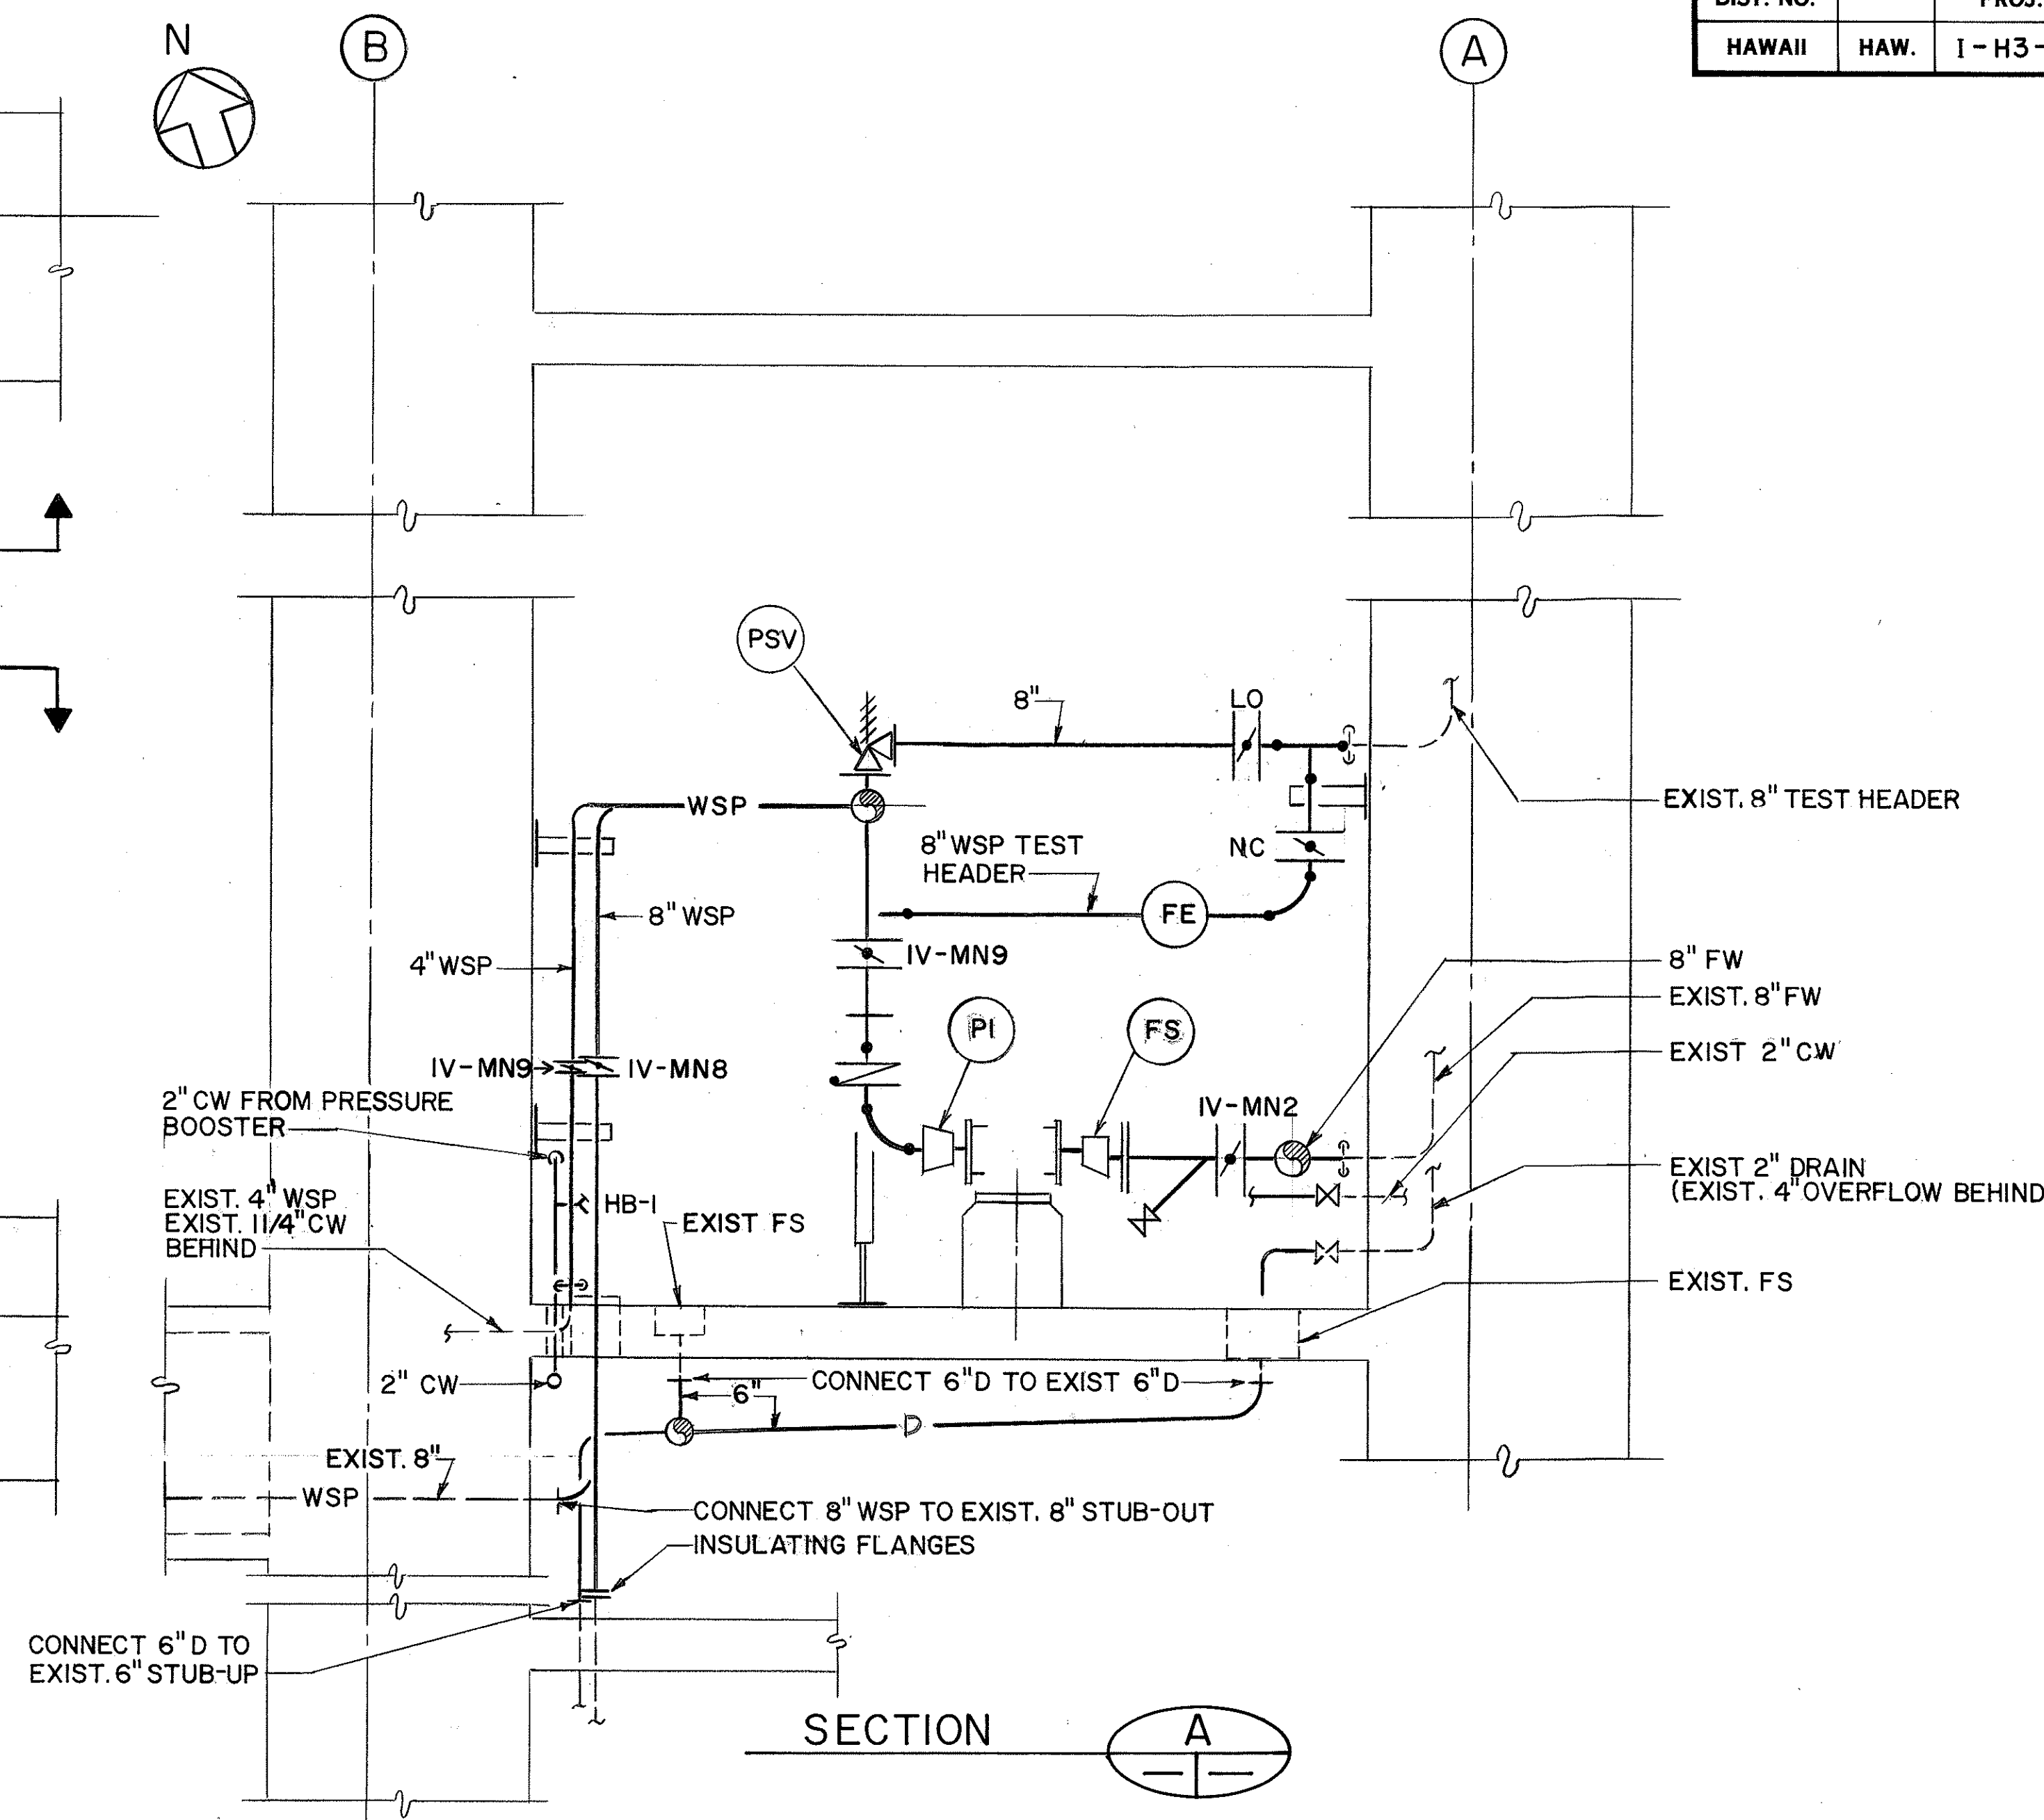

SECTION A

ORIGINAL PLAN	DATE	01/22/90
DESIGNED BY	P. L. LAIOUE	
TRACED BY	P. L. LAIOUE	
QUANTITIES BY	J. N. QUE	
CHECKED BY	J. N. QUE	
NO.	0504/90	

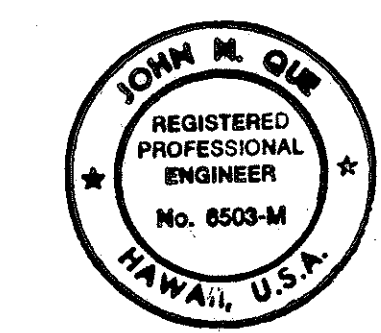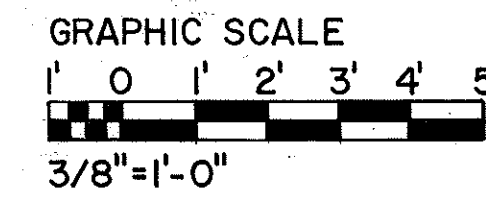


THIS WORK WAS PREPARED BY ME OR UNDER MY SUPERVISION


DATE	REVISION

STATE OF HAWAII	
DEPARTMENT OF TRANSPORTATION	
HIGHWAYS DIVISION	
PLUMBING - PUMP ROOM	
PARTIAL PLANS & SECTION	
HALAWA PORTAL BUILDING - IB	
INTERSTATE ROUTE H-3	
F.A.I. PROJ. NO. I-H3-1 (66)	
SCALE: 3/8" = 1'-0"	DATE: APR. 1992
SHEET NO. MN5 OF 8 SHEETS	


FED. ROAD DIST. NO.	STATE	FED. AID PROJ. NO.	FISCAL YEAR	SHEET NO.	TOTAL SHEETS
HAWAII	HAW.	I - H3 - I (66)	1992	46	440

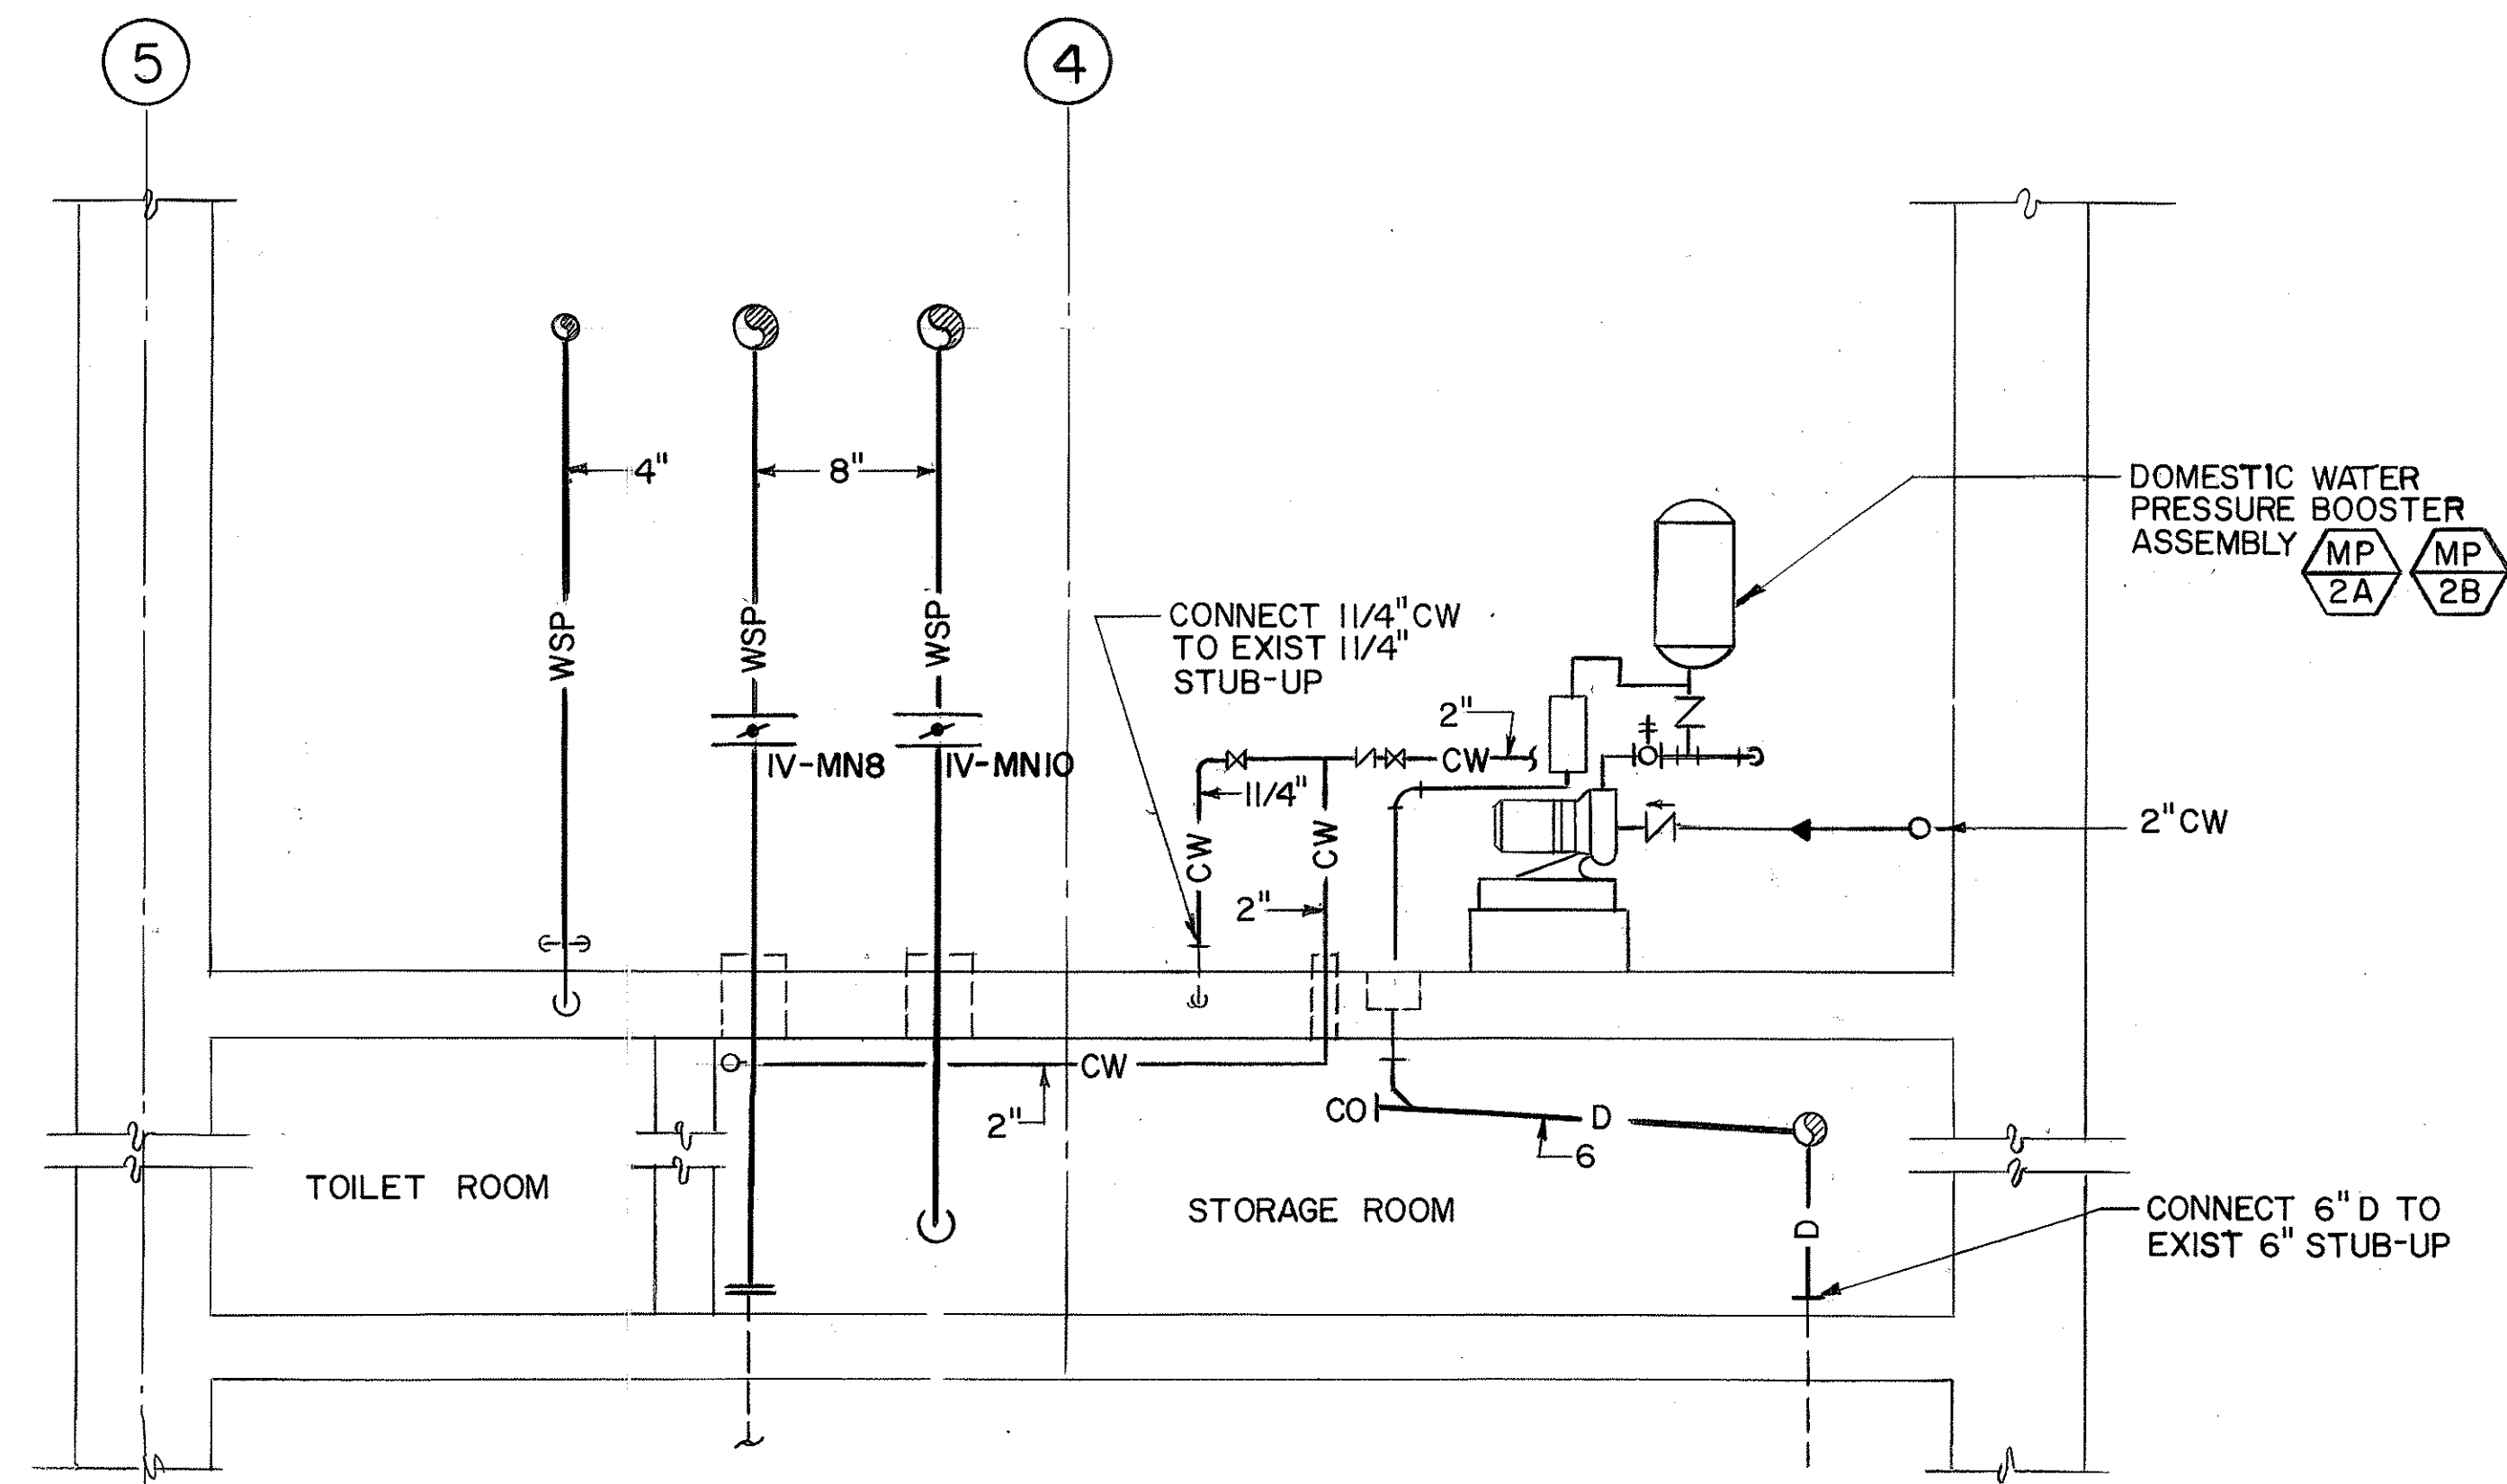

SECTION

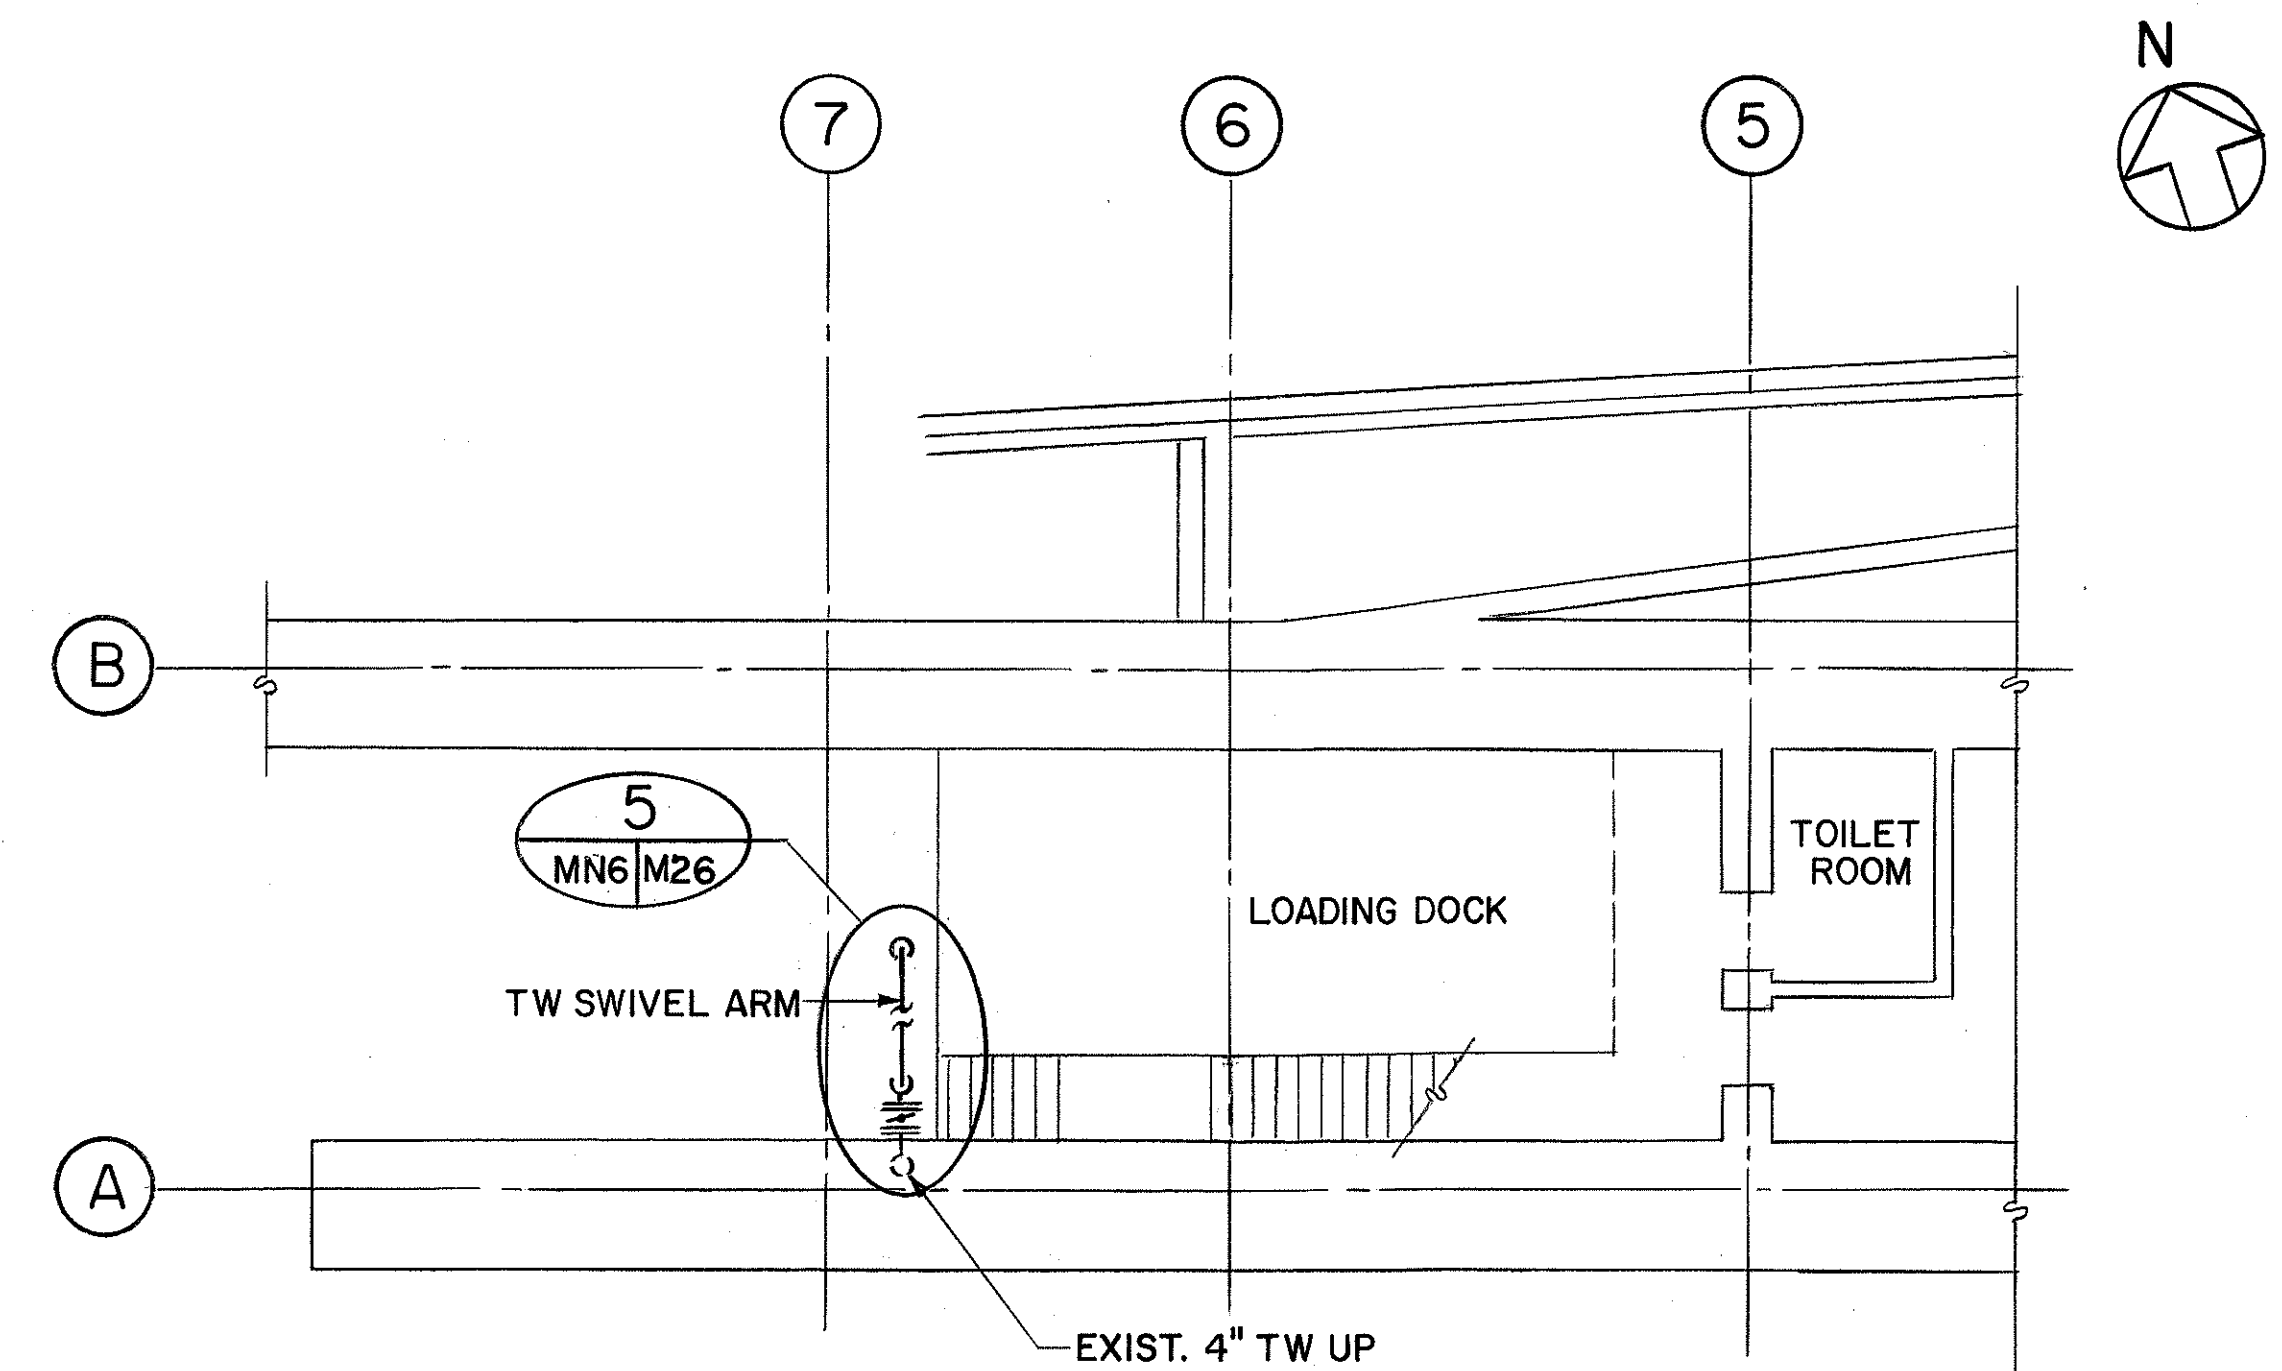



LEVEL 1 PARTIAL PLAN
SCALE: 1/8"=1'-0"

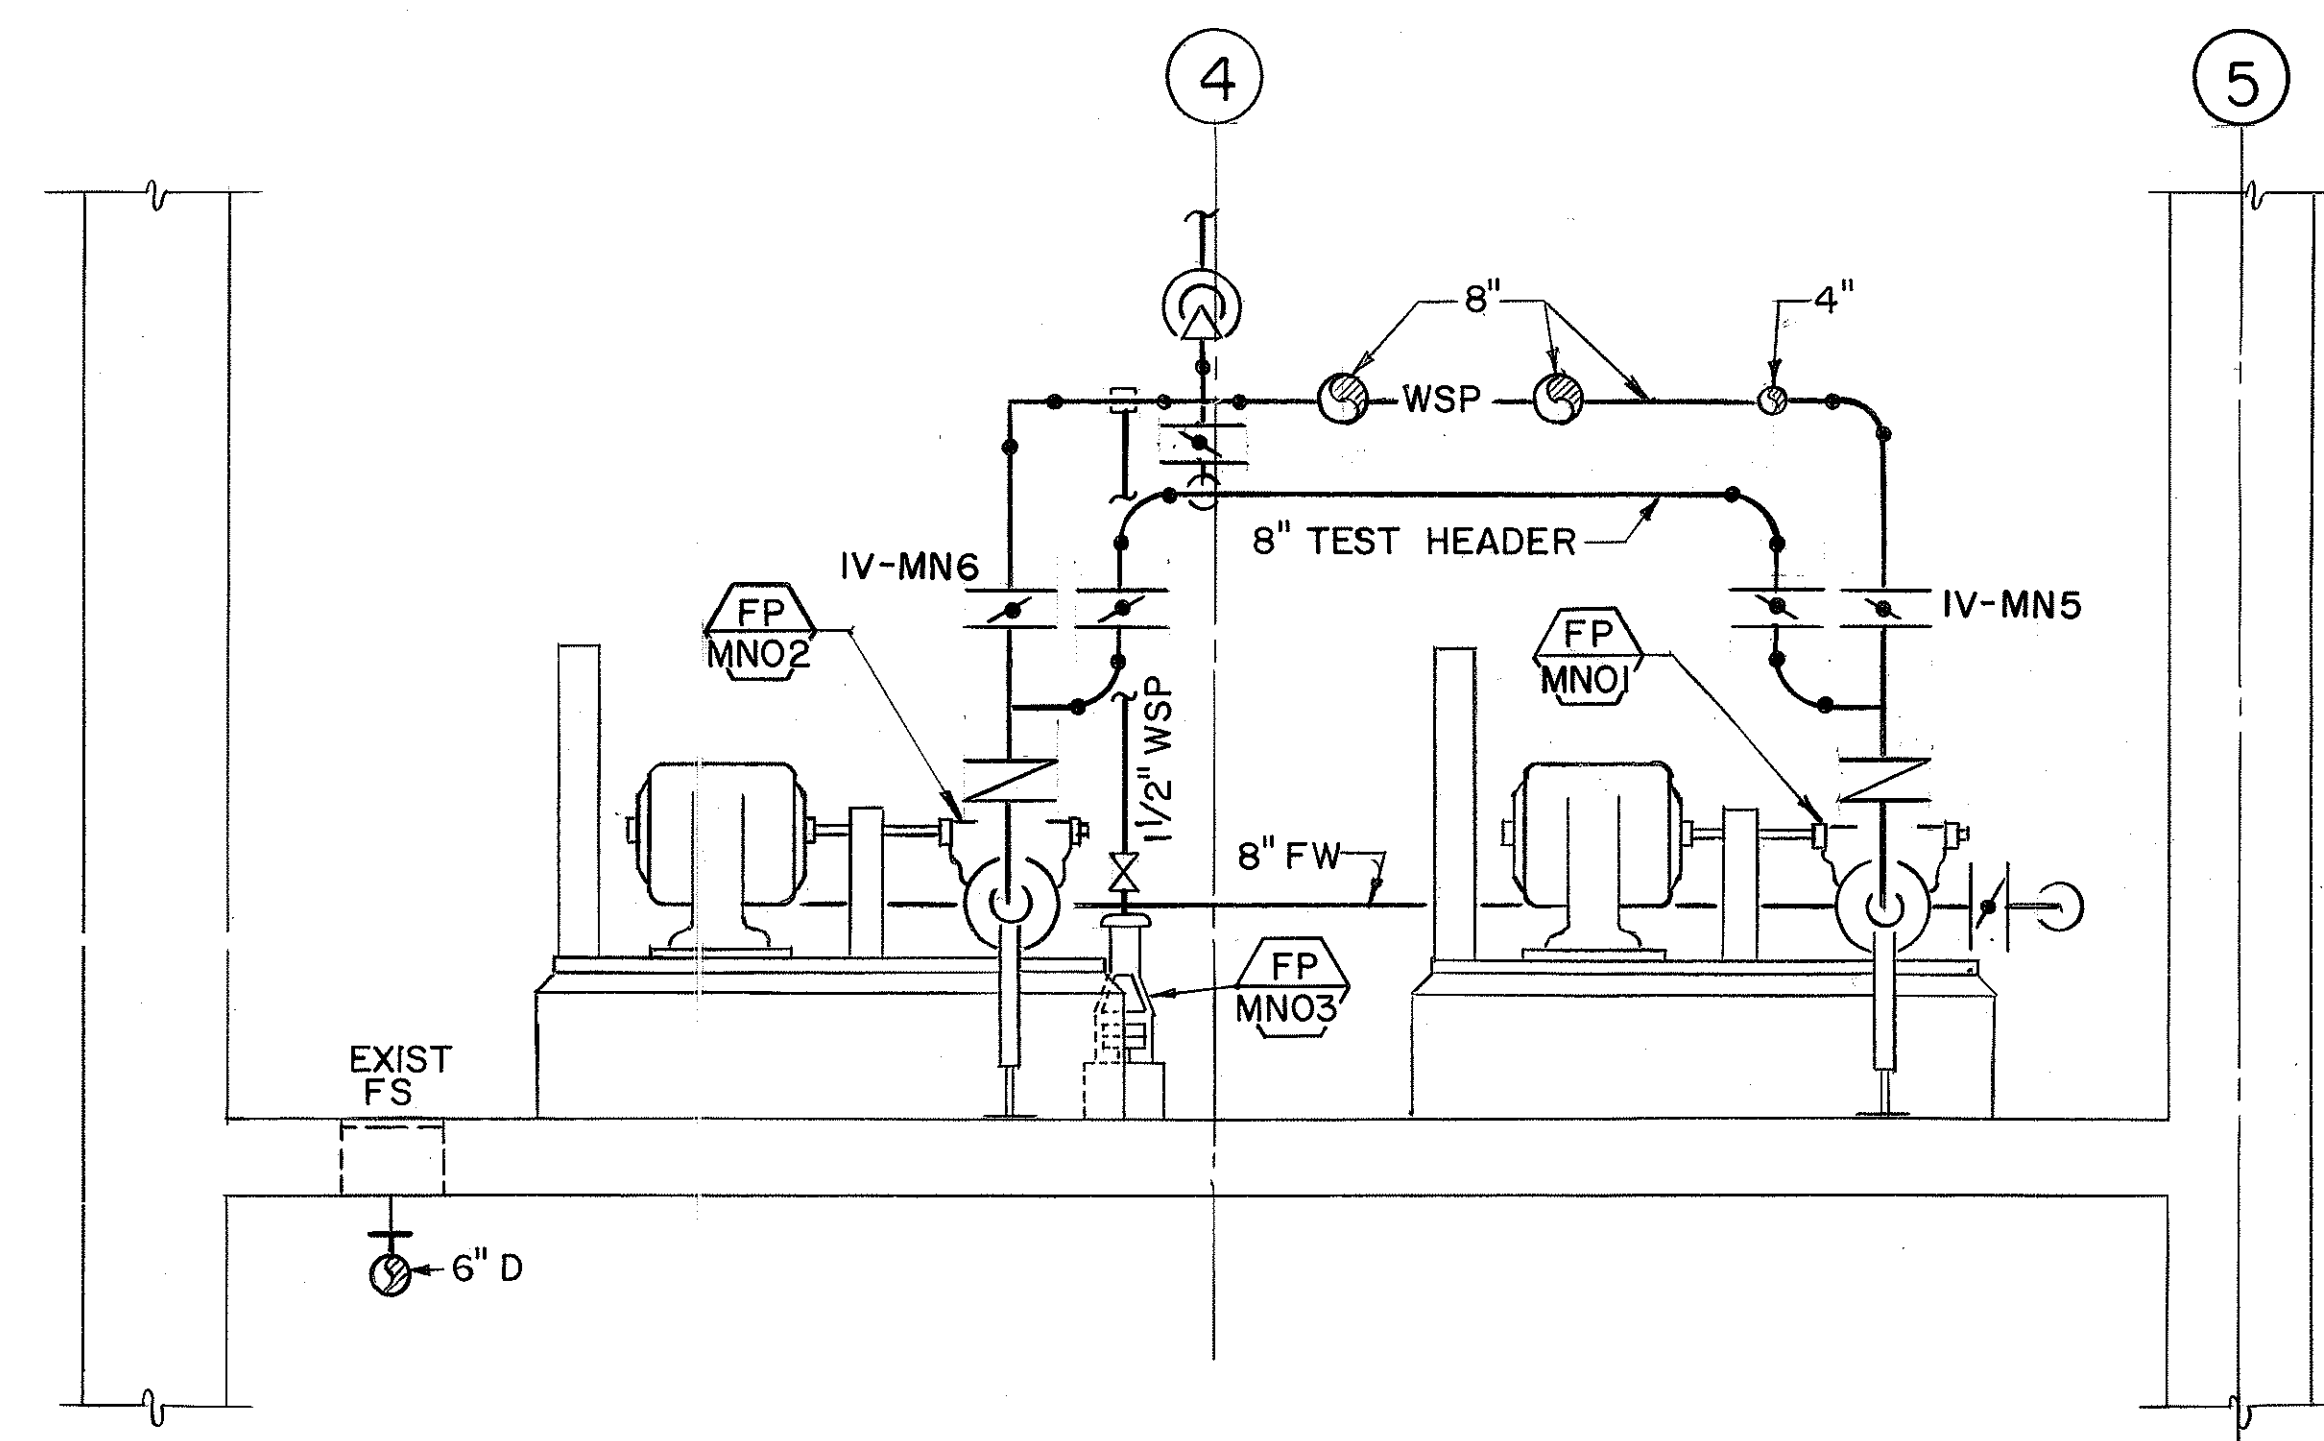

SECTION

ORIGINAL PLAN	SURVEY PLOTTED BY _____ DRAWN BY _____ TRACED BY _____ DESIGNED BY _____ QUANTITIES BY _____ CHECKED BY _____	DATE _____ 01/04/90 12/17/89 06/04/90
NOTE BOOK		
No. _____		

GRAPHIC SCALES

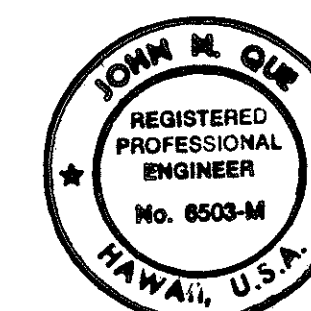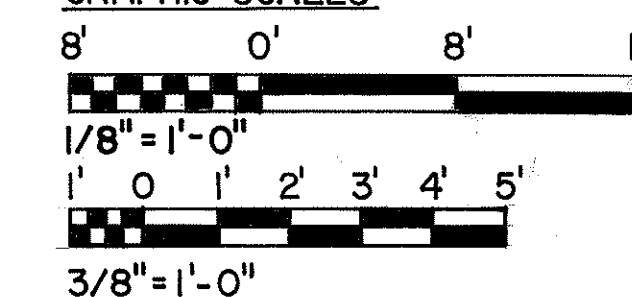

THIS WORK WAS PREPARED BY ME
OR UNDER MY SUPERVISION

DATE	REVISION
------	----------

STATE OF HAWAII
DEPARTMENT OF TRANSPORTATION
HIGHWAYS DIVISION

PARTIAL PLAN & PUMP ROOM SECTIONS

INTERSTATE ROUTE H-3
F.A.I. PROJ. NO. I-H3-1 (66)

SCALE : AS NOTED DATE : APR 1992

SHEET NO. MN6 OF 8 SHEETS

N




SCALE: 1/8" = 1'-0" DATE: APR 1992

SHEET NO. MN7 OF 8 SHEETS

GRAPHIC SCALE

8' 0' 8' 16'


1/8" = 1'-0"

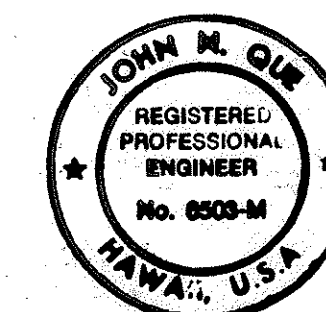


THIS WORK WAS PREPARED BY ME
OR UNDER MY SUPERVISION

John M. Dugan



FED. ROAD DIST. NO.	STATE	FED. AID PROJ. NO.	FISCAL YEAR	SHEET NO.	TOTAL SHEETS
HAWAII	HAW.	1-H3-1(66)	1992	48	440

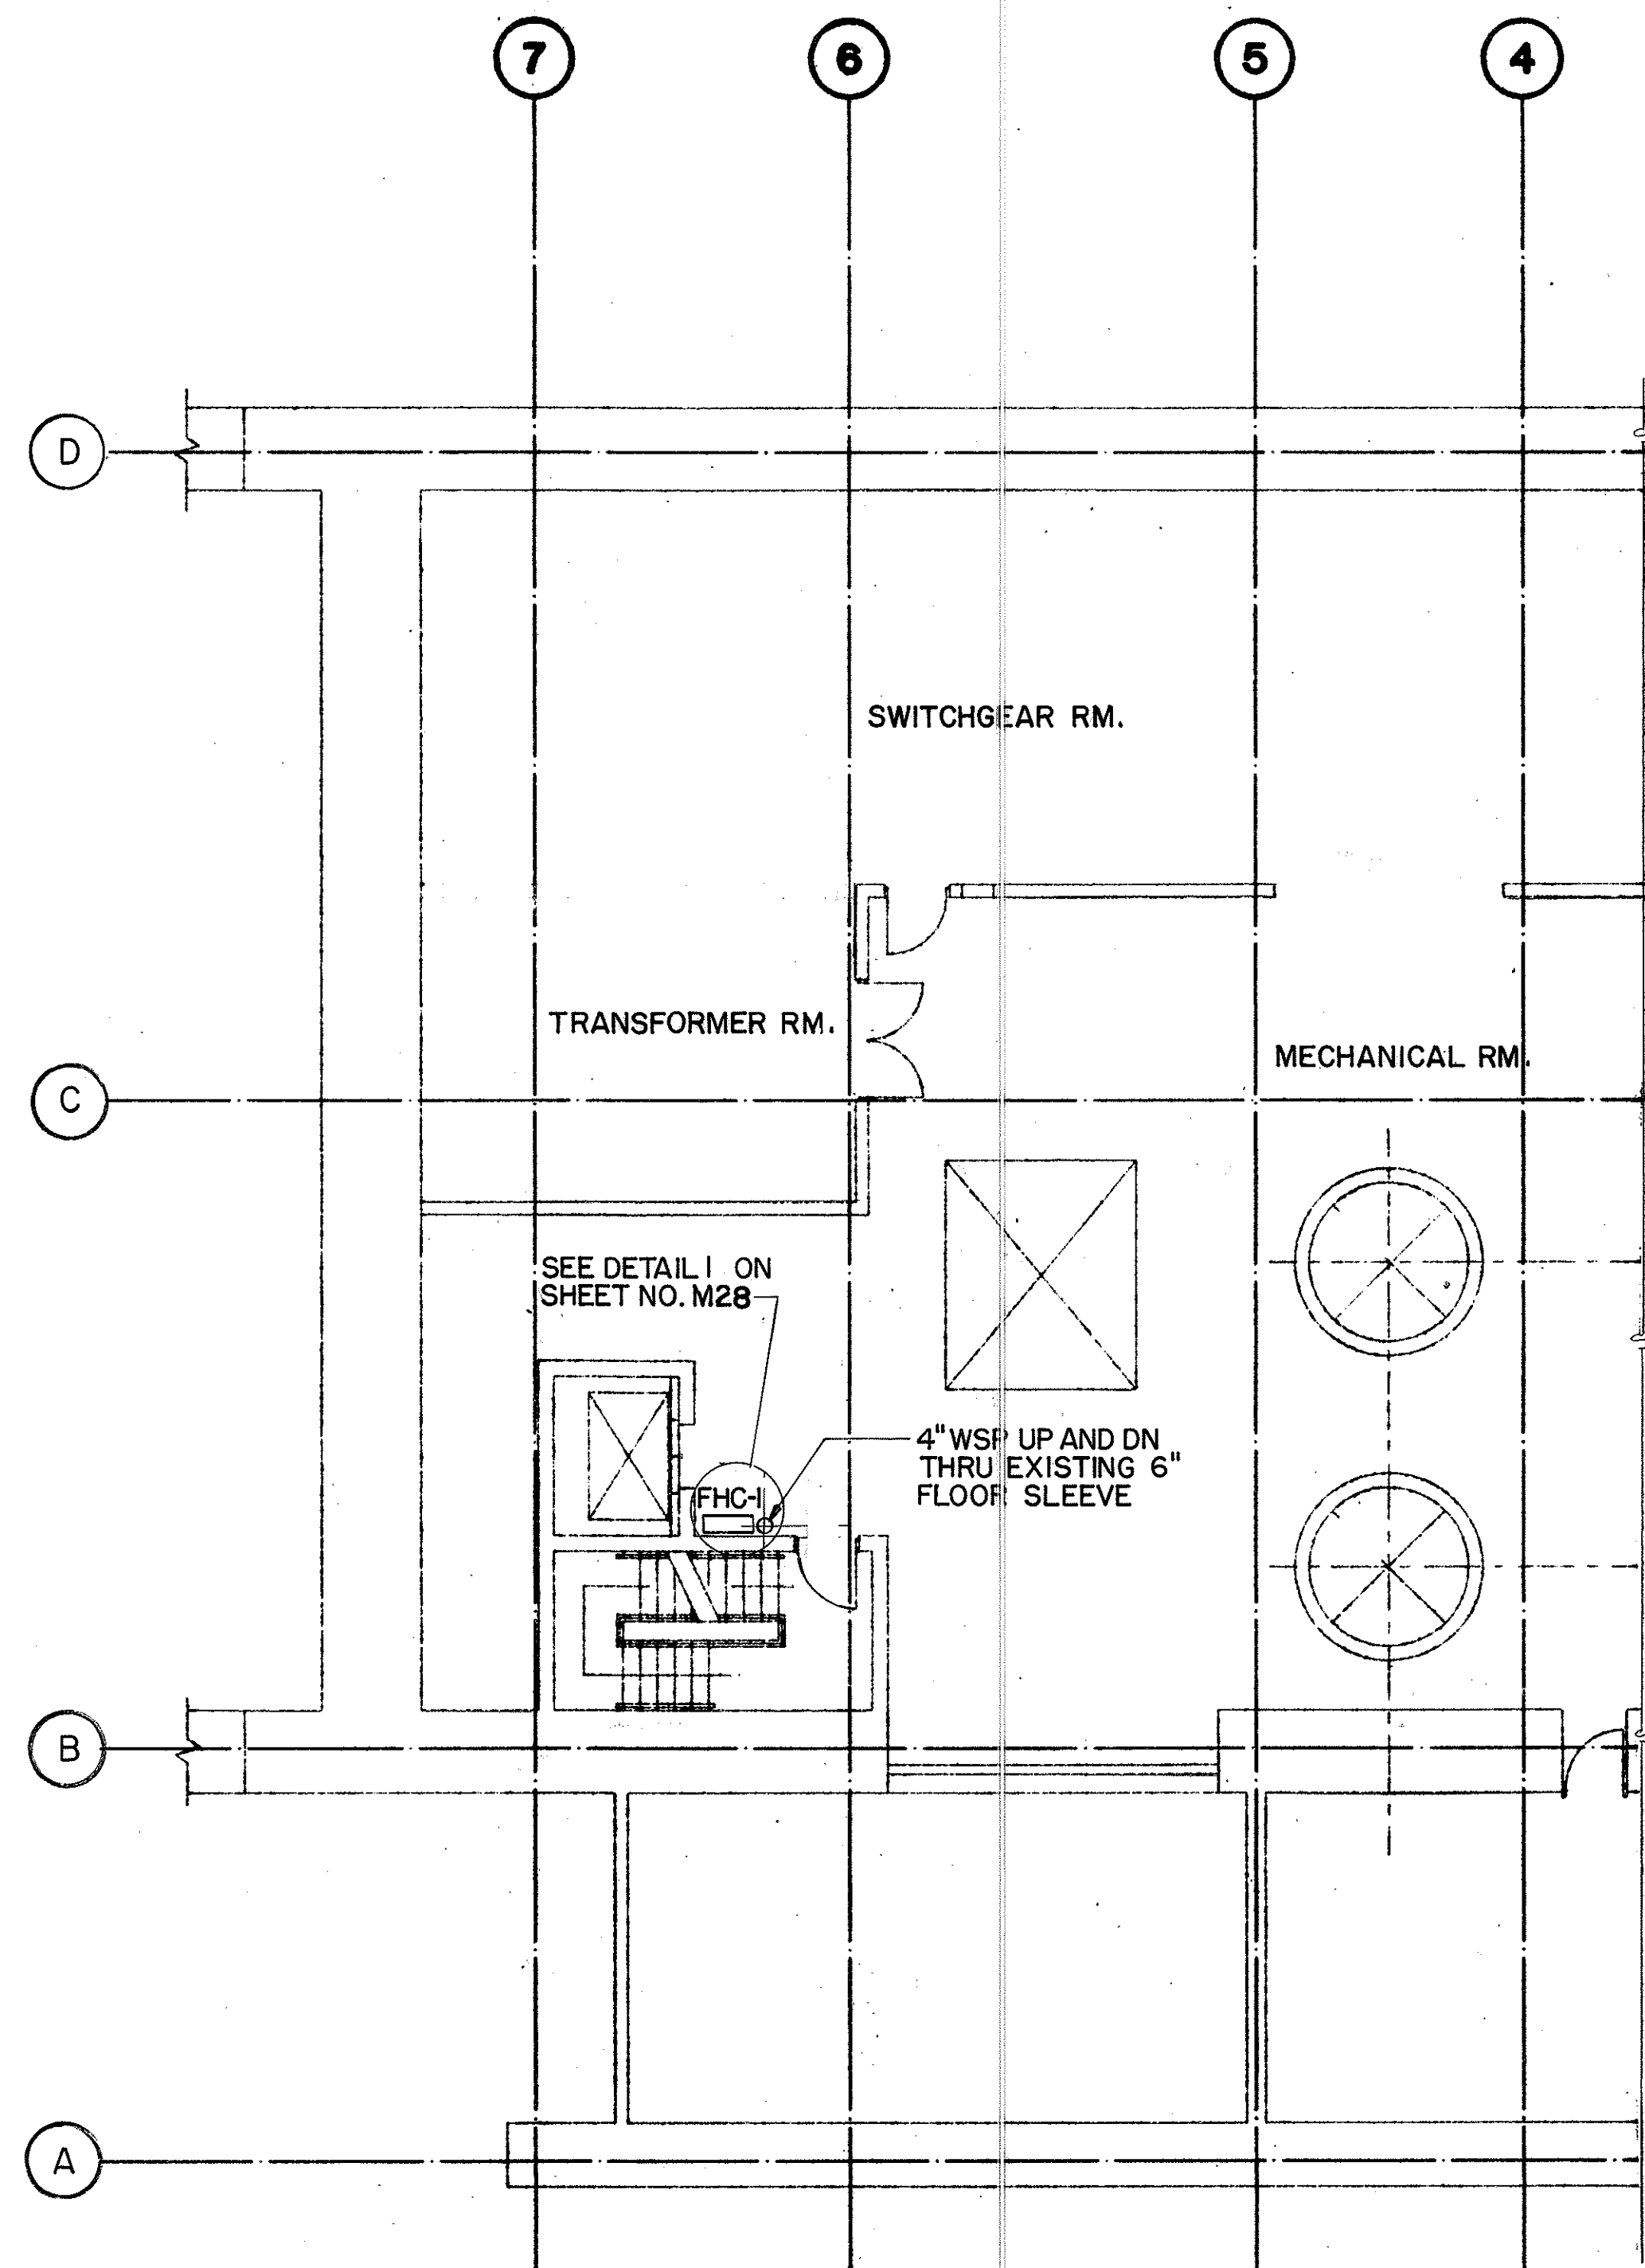

LEVEL 4 PLAN

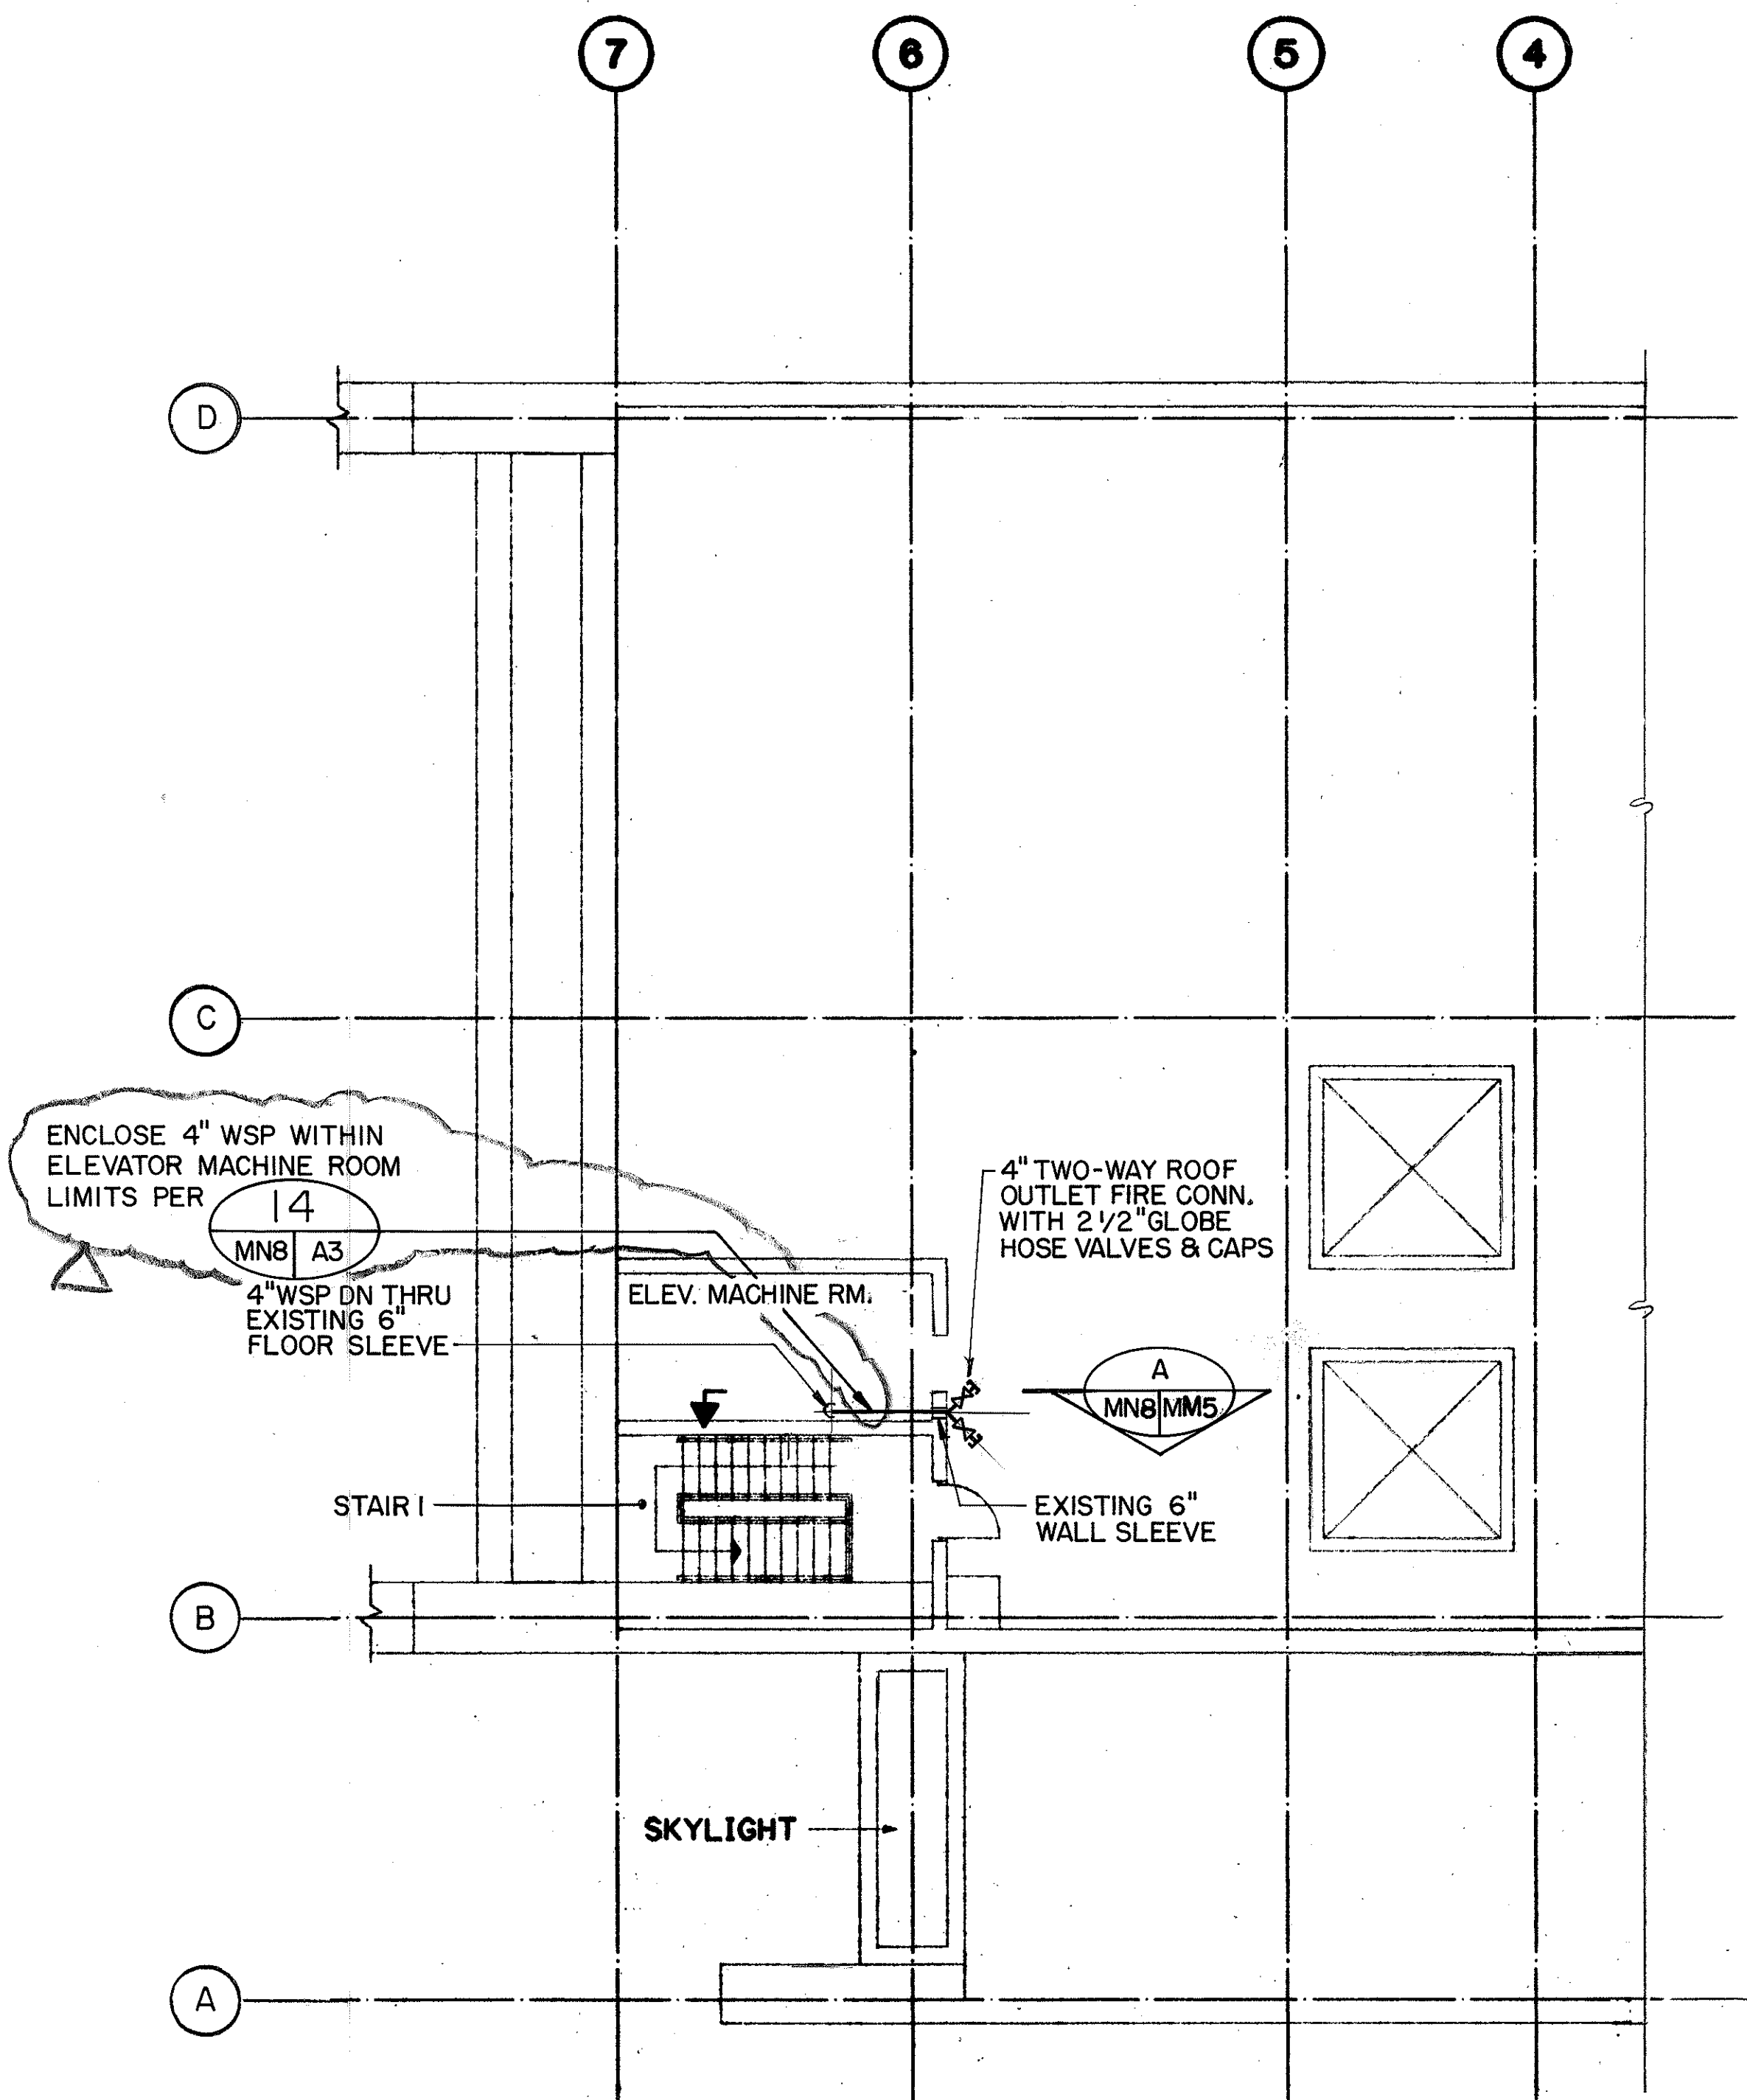

ROOF LEVEL PLAN

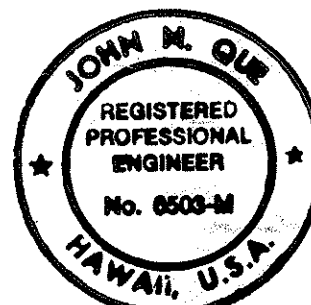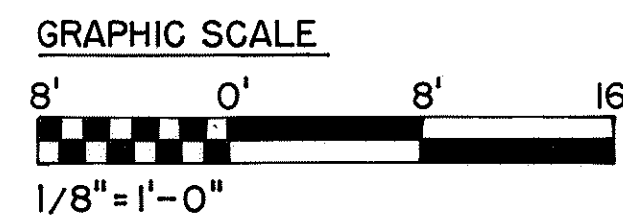


THIS WORK WAS PREPARED BY ME
OR UNDER MY SUPERVISION

9/19/94	REV. PER DCN 66-052
DATE	REVISION
STATE OF HAWAII DEPARTMENT OF TRANSPORTATION HIGHWAYS DIVISION FIRE PROTECTION-LEVEL 4 & ROOF PARTIAL PLANS & SECTION HALAWA PORTAL BUILDING - 1B INTERSTATE ROUTE H-3 F.A.I. PROJ. NO. 1-H3-1 (66)	
SCALE: 1/8"=1'-0"	DATE: APR 1992
SHEET NO. MN8 OF 8 SHEETS	

ORIGINAL PLAN	SURVEY PLOTTED BY B. FEBUNYI, JR.	DATE 11/8/89
NOTE BOOK	DESIGNED BY P. LALLOUE	11/7/89
	CHECKED BY J. N. QUE	06/05/90

FED. ROAD DIST. NO.	STATE	FED. AID PROJ. NO.	FISCAL YEAR	SHEET NO.	TOTAL SHEETS
HAWAII	HAW.	I - H3 - I (66)	1992	49	440

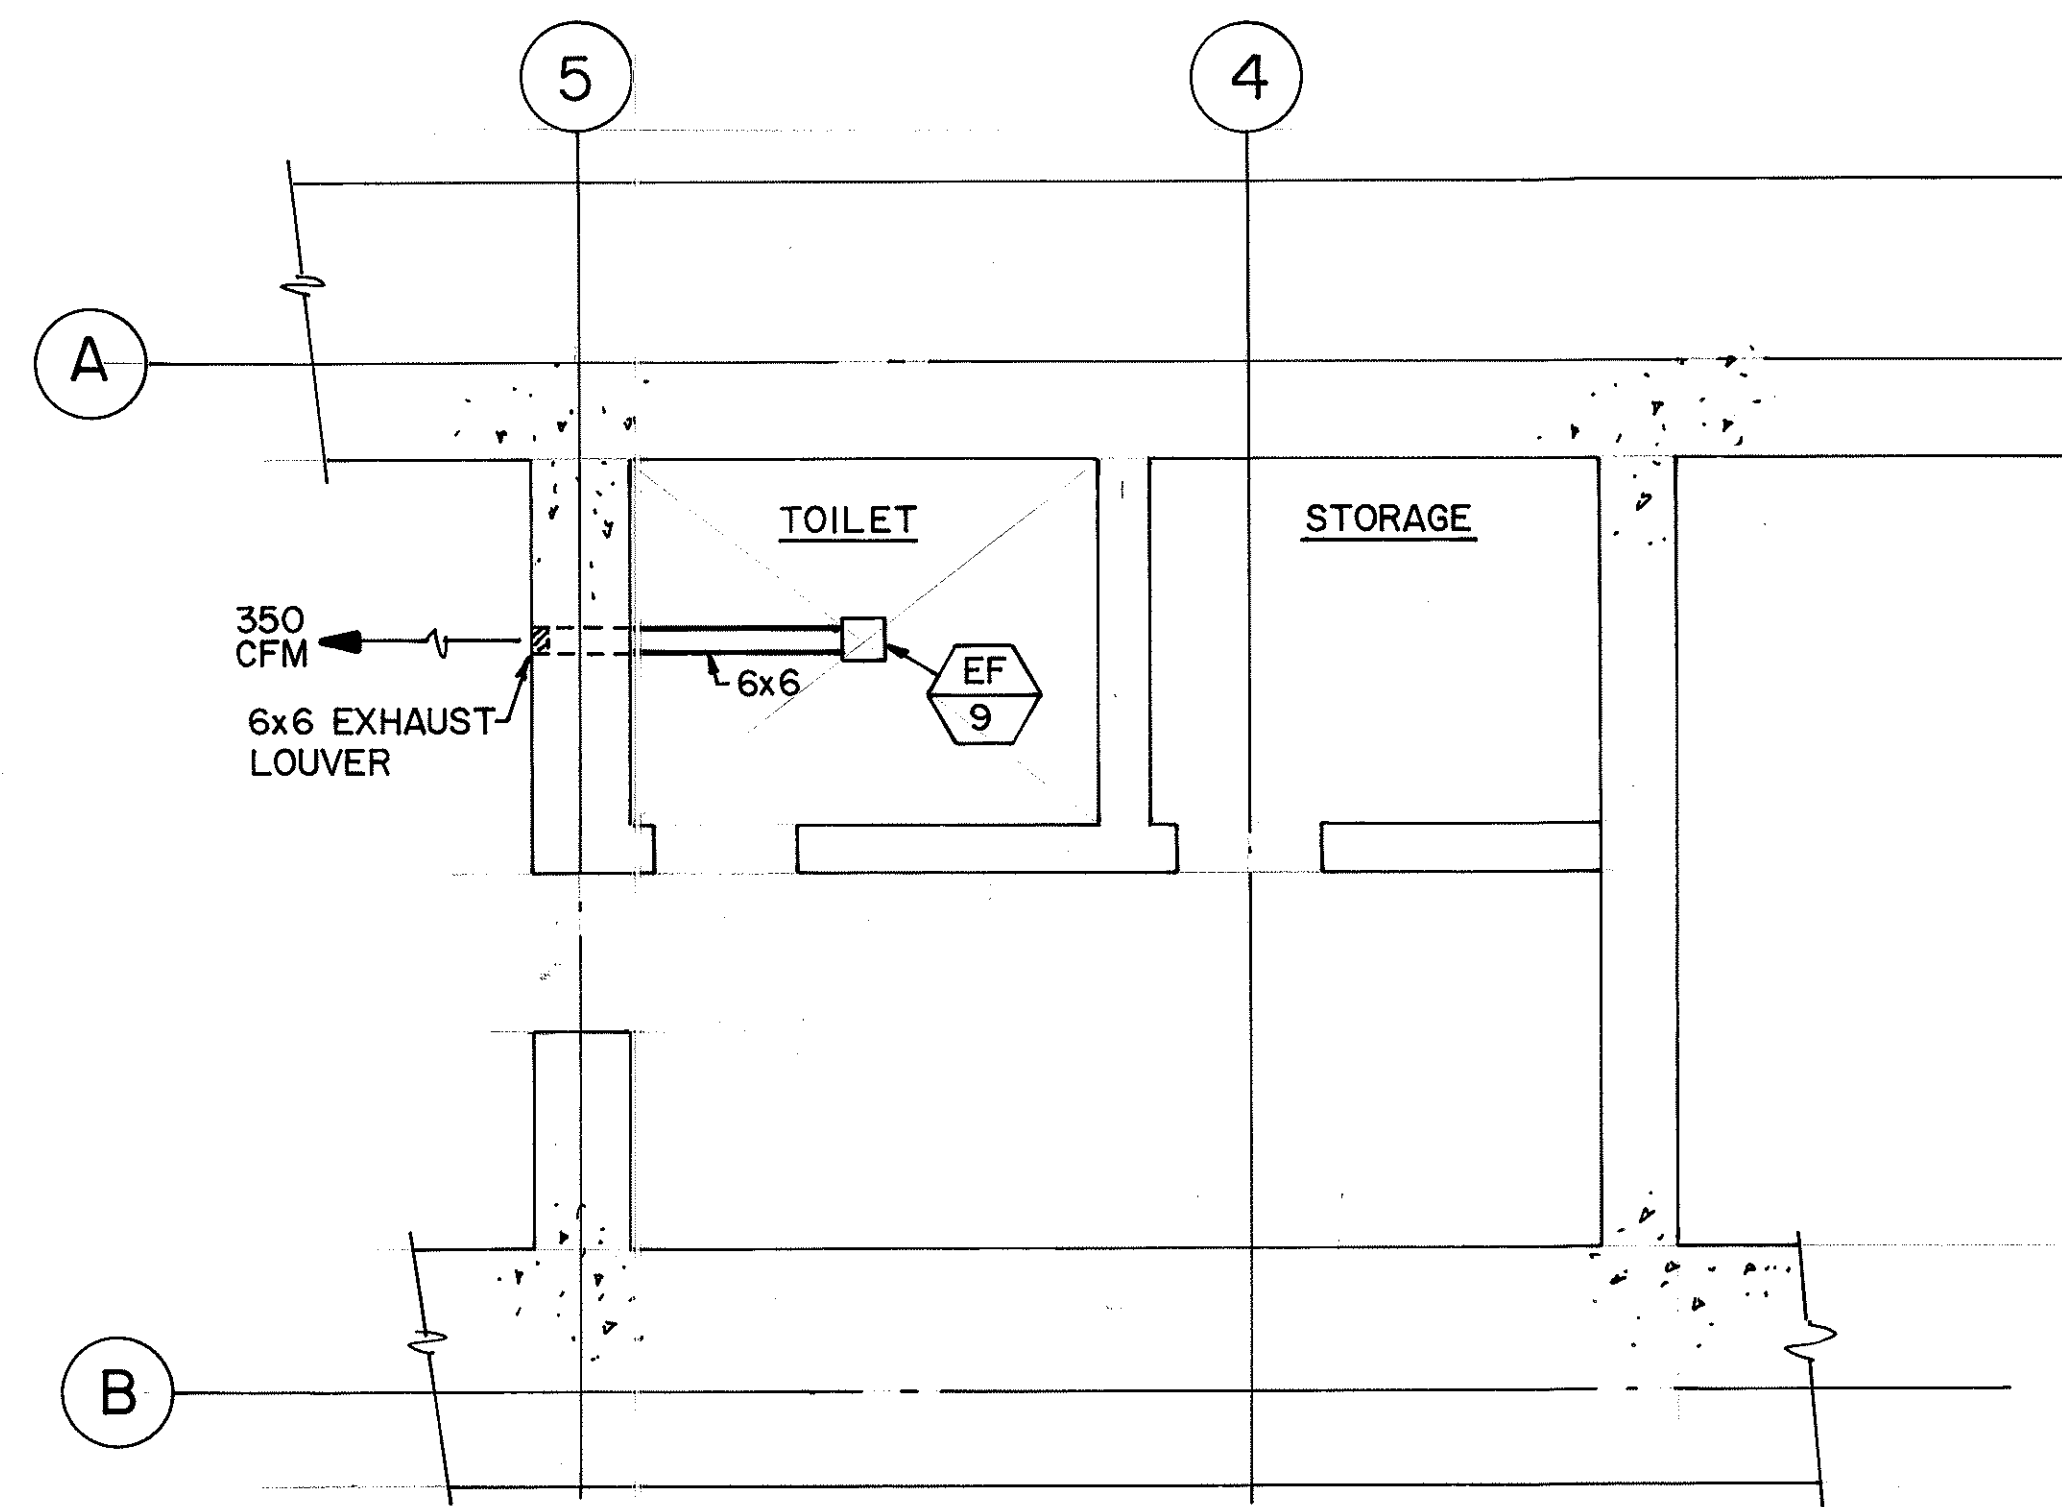

LEVEL 2 PARTIAL PLAN

**FOR DETAIL AS-BUILT INFORMATION
REFER TO CONSTRUCTION SUBMITTALS**


DATE	REVISION

STATE OF HAWAII
DEPARTMENT OF TRANSPORTATION
HIGHWAYS DIVISION
HVAC-LEVEL 2
PARTIAL PLAN
HALAWA PORTAL BUILDING-0B
INTERSTATE ROUTE H-3
F.A.I. PROJ. NO. I-H3-1 (66)

SCALE : 1/4" = 1'-0" DATE : APR 1992
SHEET NO. MOI OF 6 SHEETS

ORIGINAL PLAN	SURVEY PLOTTED BY _____ DATE _____
NOTE BOOK	DRAWN BY <u>D. E. DRYDEN</u>
	TRACED BY _____
	DESIGNED BY <u>D. E. DRYDEN</u>
	QUANTITIES BY _____
No. _____	CHECKED BY <u>J. N. QUE</u> DATE <u>6/05/90</u>

GRAPHIC SCALE
1' 0' 1' 2' 3' 4' 5'
1/4" = 1'-0"


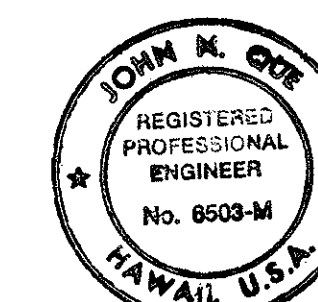


THIS WORK WAS PREPARED BY ME
OR UNDER MY SUPERVISION

John Doe



FED. ROAD DIST. NO.	STATE	FED. AID PROJ. NO.	FISCAL YEAR	SHEET NO.	TOTAL SHEETS
HAWAII	HAW.	I - H3-1(66)	1992	50	440

NOTE:
CONTRACTOR SHALL PROVIDE AND INSTALL CLOSURE FOR OPENING. EDGES OF CLOSURE PLATE SHALL BE SEALED WITH A GASKET MATERIAL OR CAULK. MATERIAL SHALL BE CARBON STEEL, GALVANIZED.

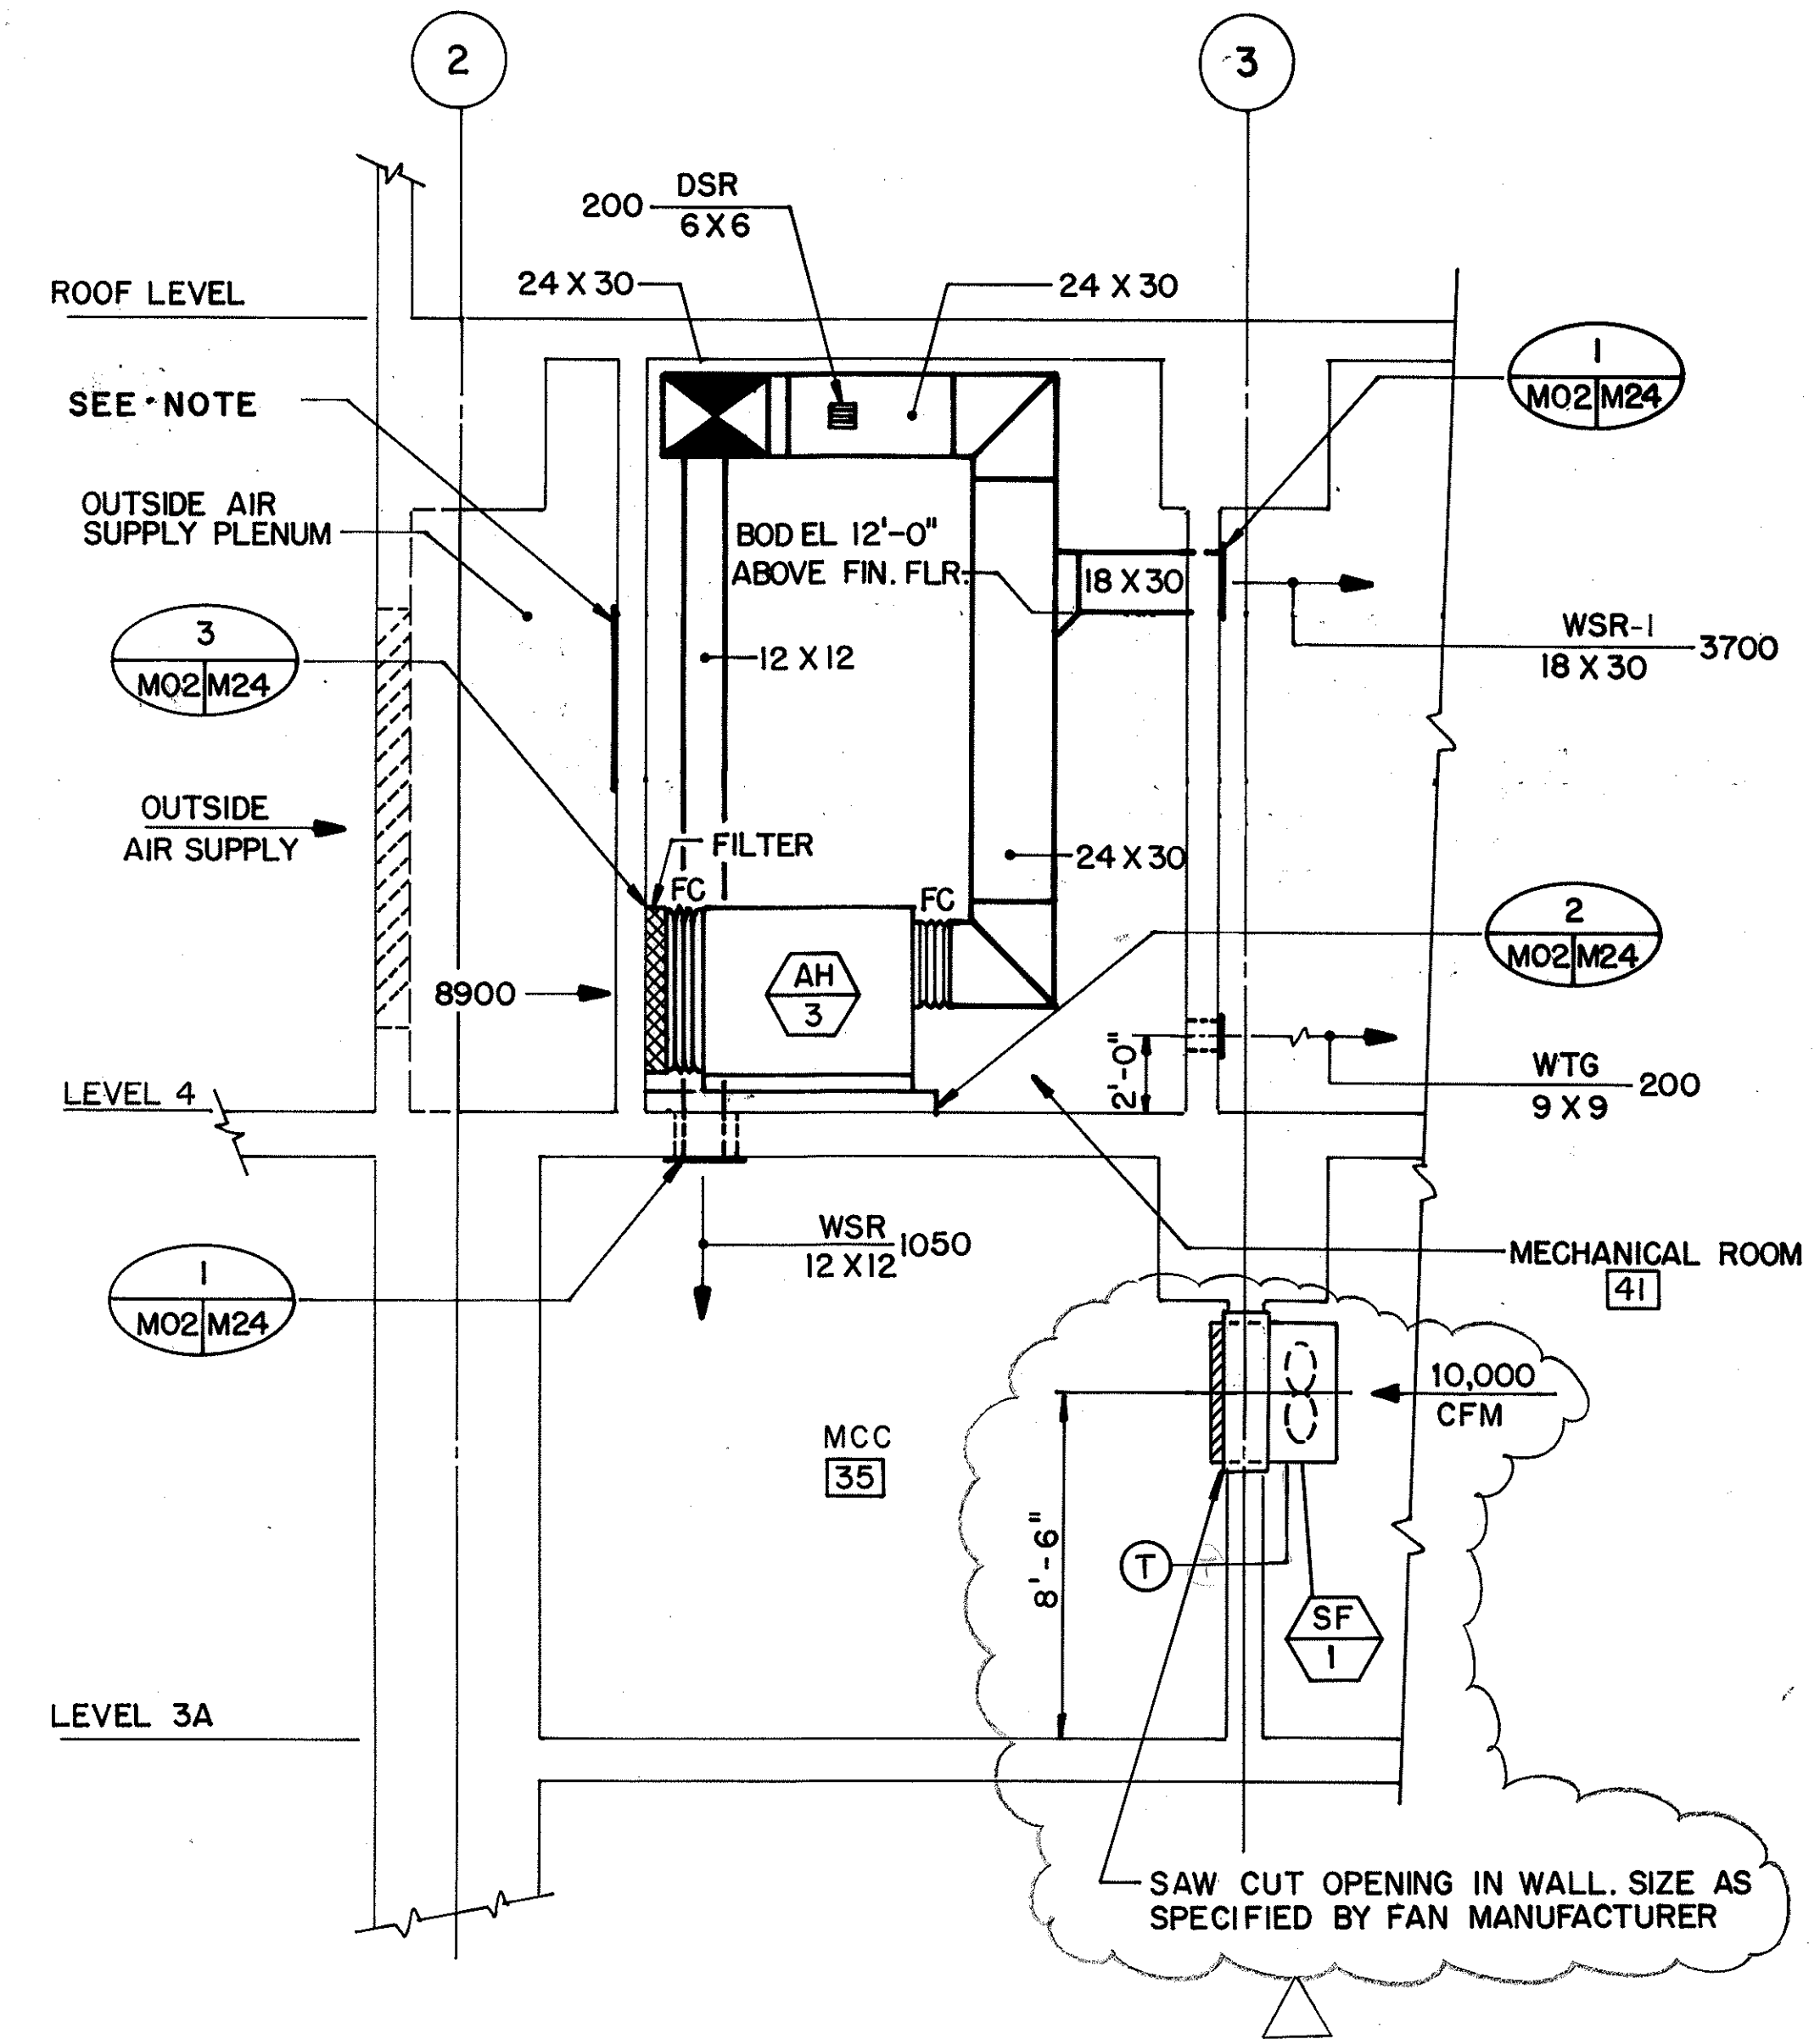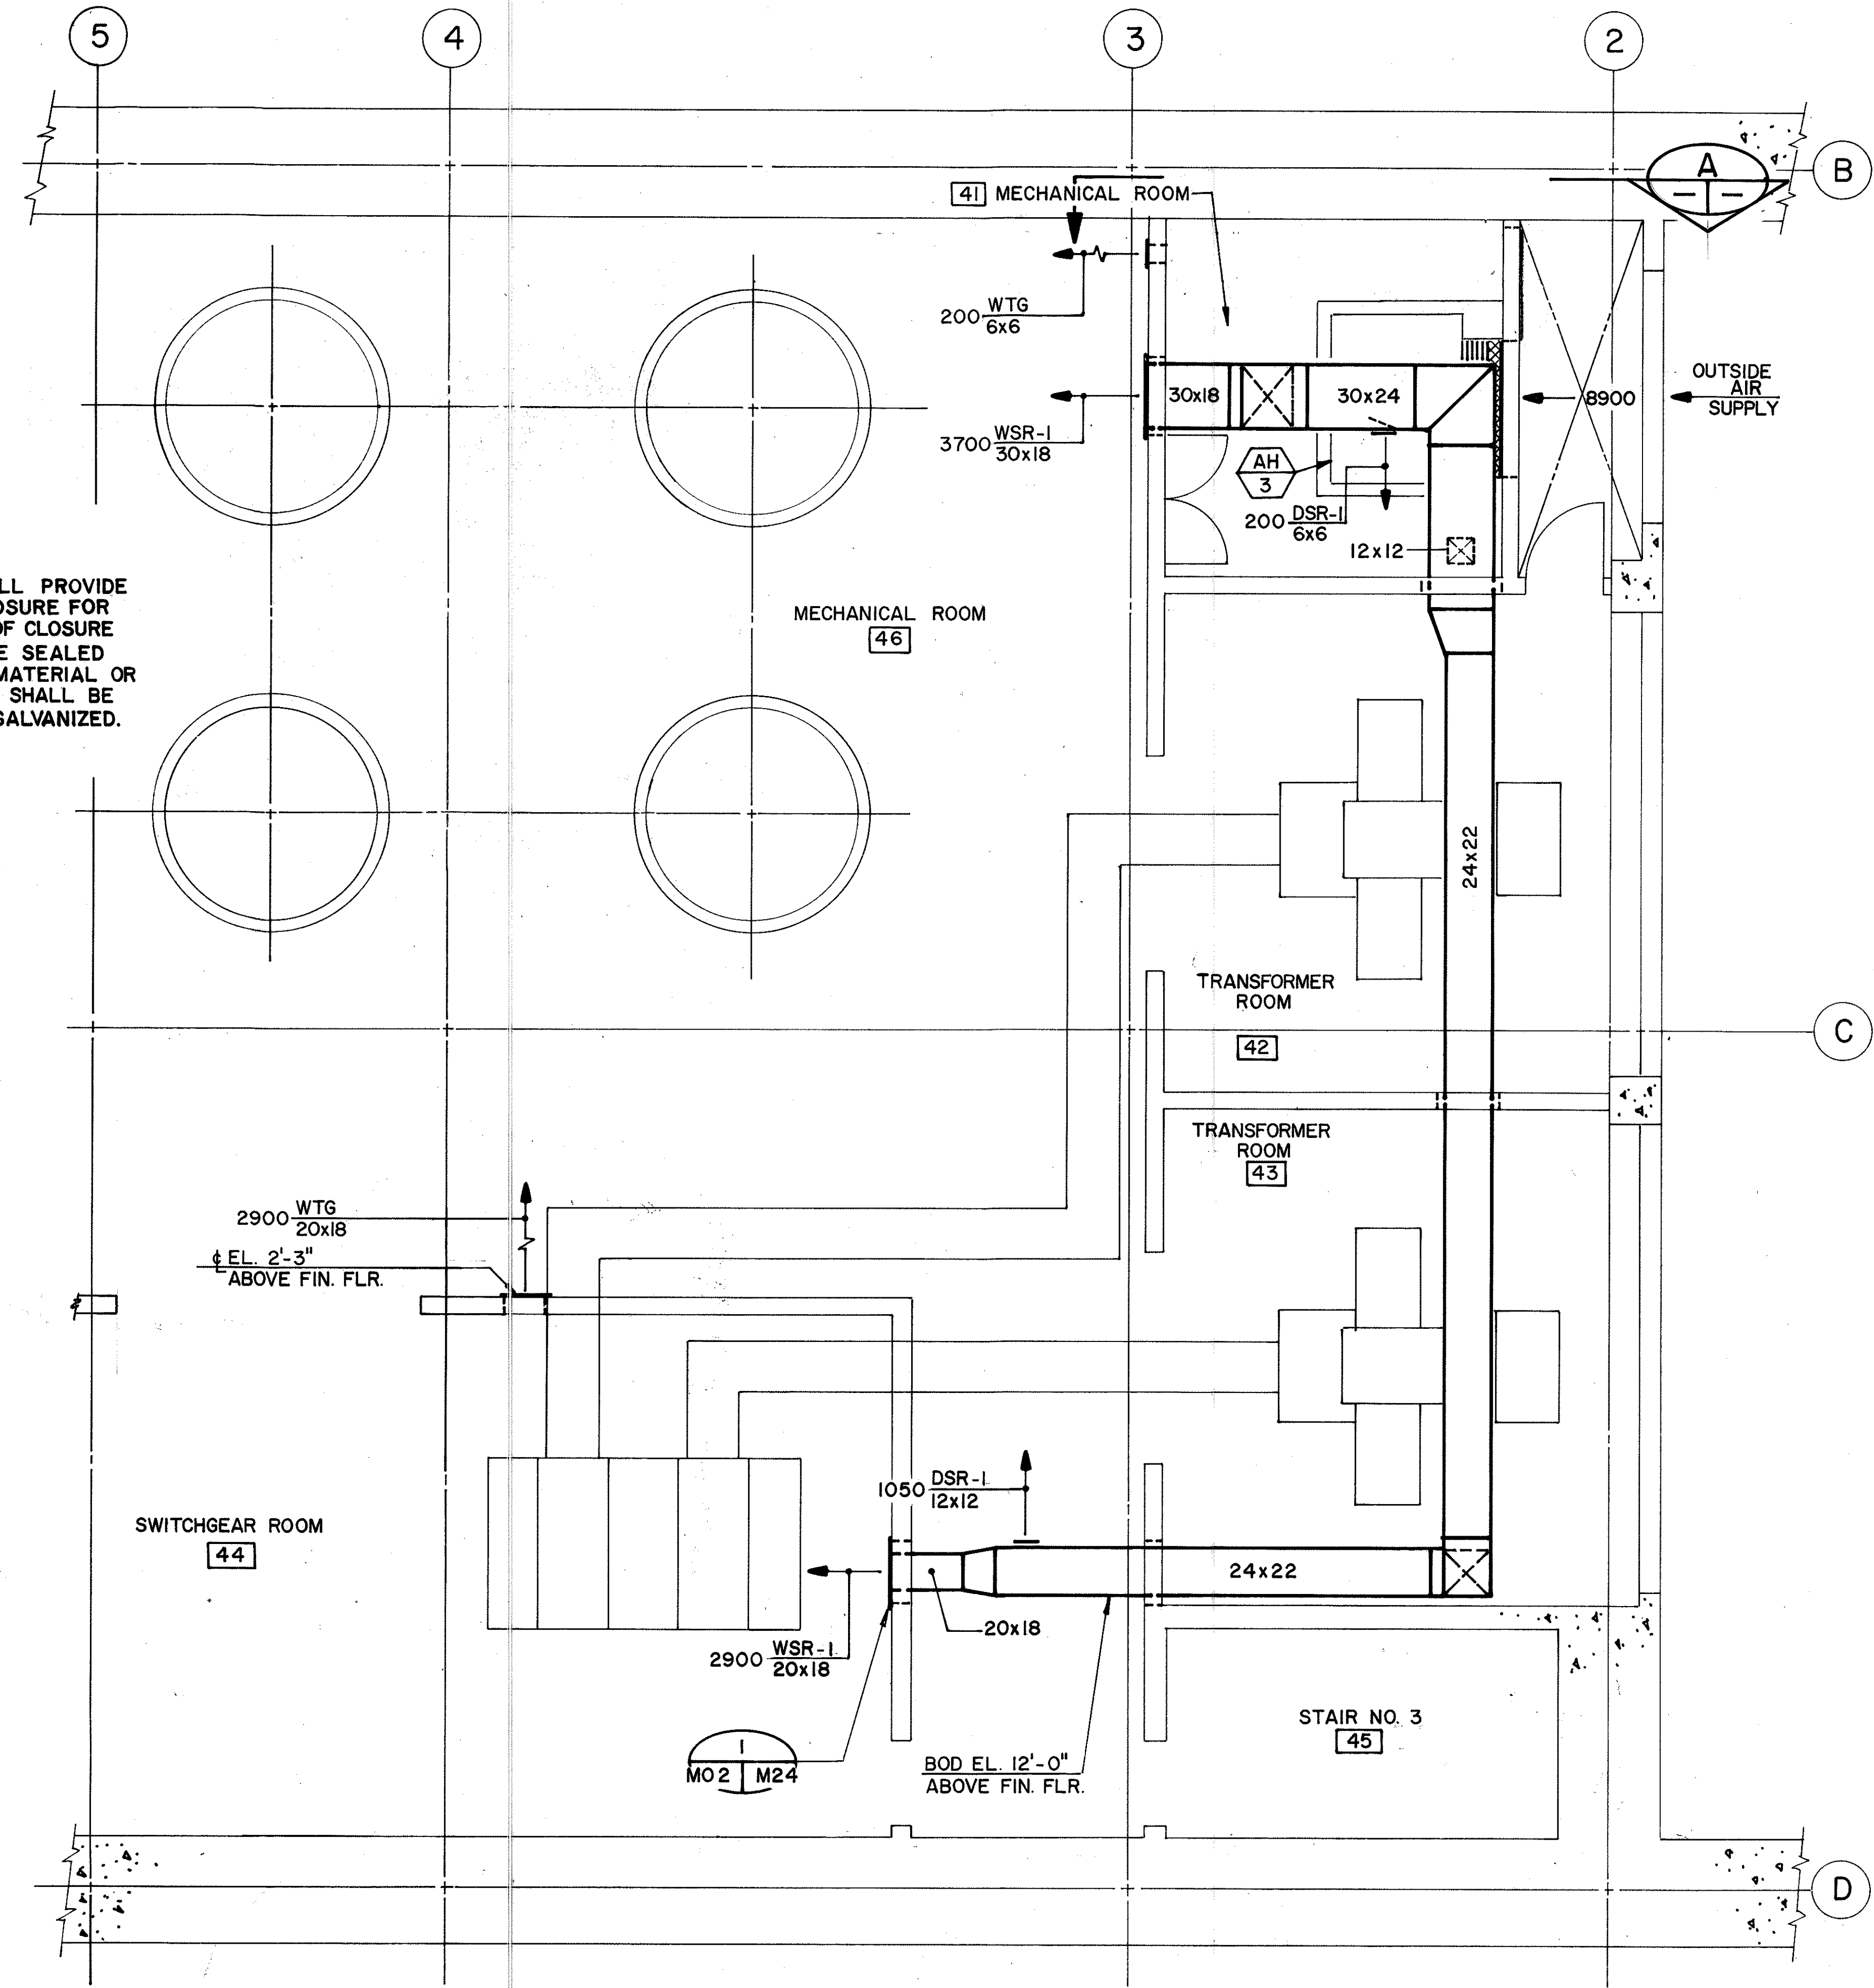

SECTION A-A

SURVEY PLOTTED BY	DATE
B. F. BUNYI	2/13/93
DRAWN BY	DESIGNED BY
D. E. DRYDEN	2/06/93
QUANTITIES BY	CHECKED BY
J. N. QUE	06/05/93


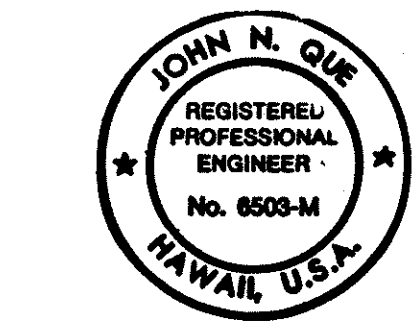
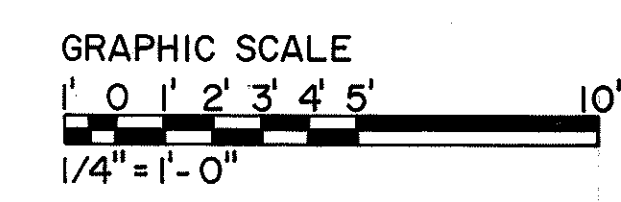


THIS WORK WAS PREPARED BY ME OR UNDER MY SUPERVISION


DATE	REVISION
3/8/94	REV. SECT. 'A', ADDED SF PER DCN 66-039
5/13/93	DELETED AUX. COOLING FANS & ASSOC. DUCTWORK PER DCN 66-004

STATE OF HAWAII DEPARTMENT OF TRANSPORTATION HIGHWAYS DIVISION	
HVAC — LEVEL 4	
PARTIAL PLAN AND SECTION	
HALAWA PORTAL BUILDING — OB	
INTERSTATE ROUTE H-3	
F.A.I. PROJ. NO. I-H3-1(66)	
SCALE: 1/4" = 1'-0"	DATE: APR 1992
SHEET NO. M02 OF 6 SHEETS	


FED. ROAD DIST. NO.	STATE	FED. AID PROJ. NO.	FISCAL YEAR	SHEET NO.	TOTAL SHEETS
HAWAII	HAW.	I-H3-1(66)	1992	51	440

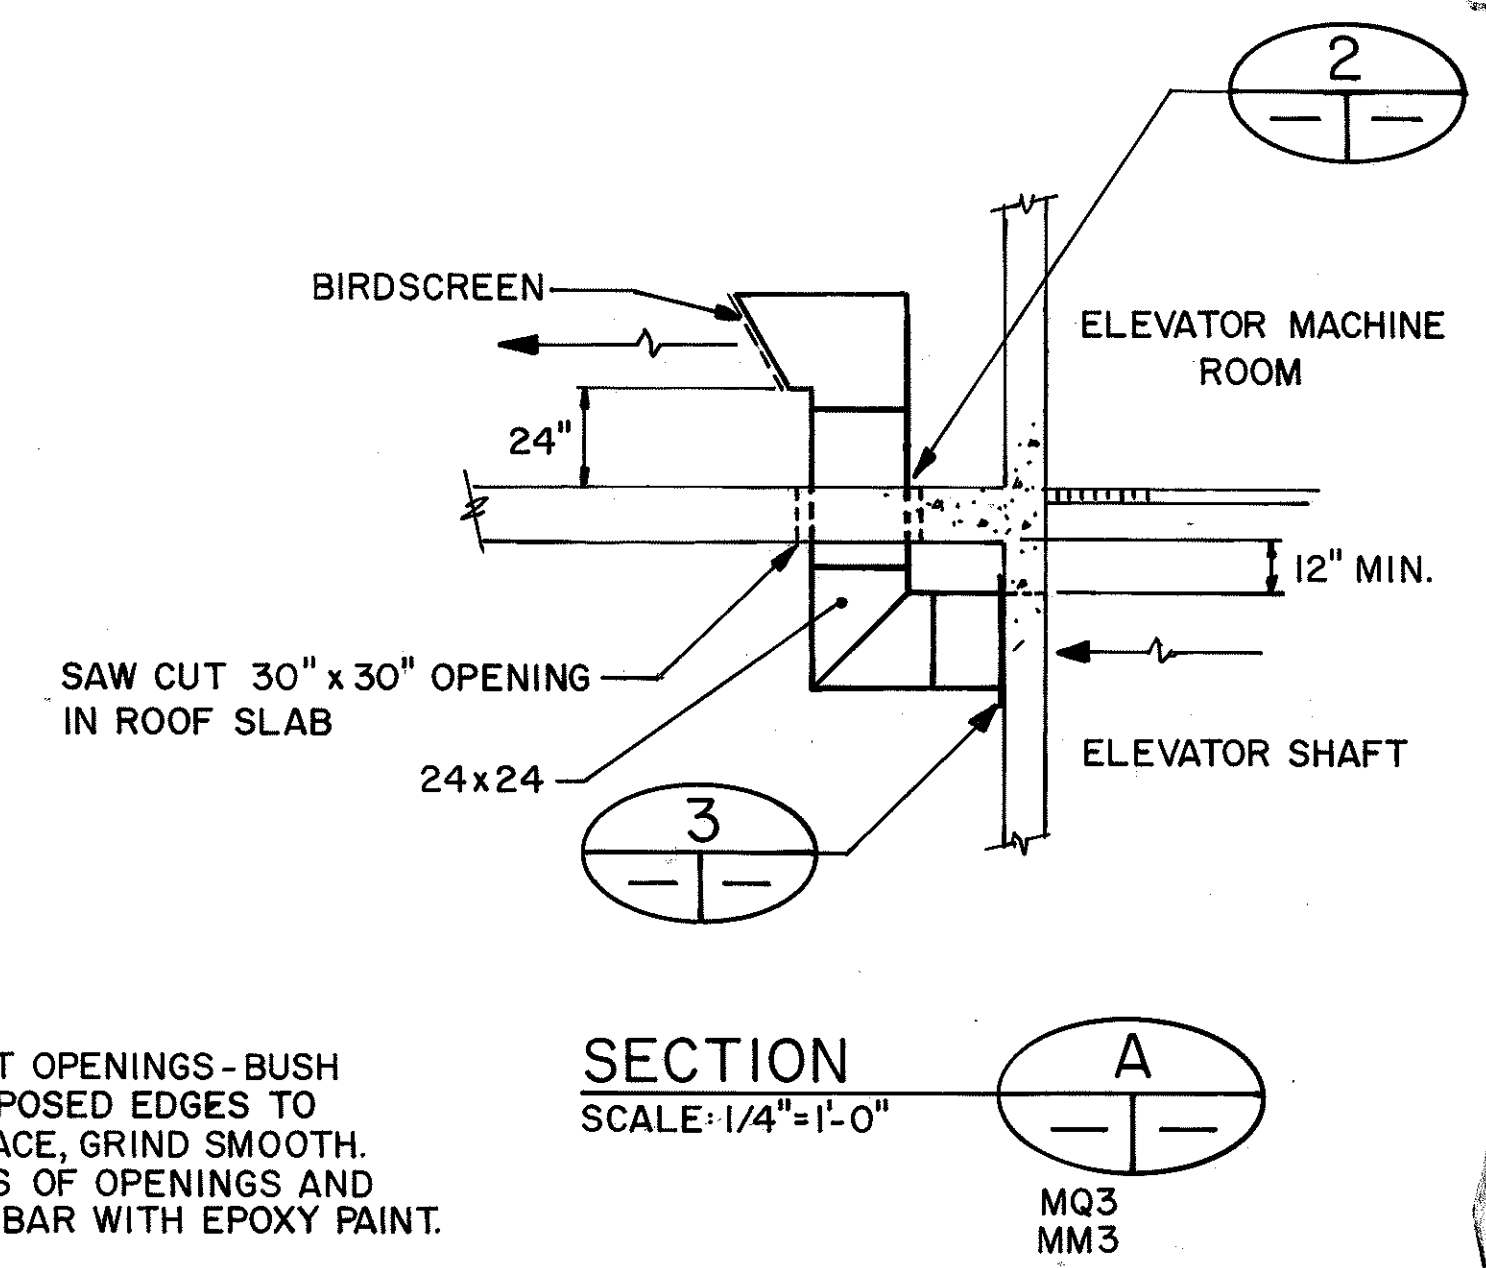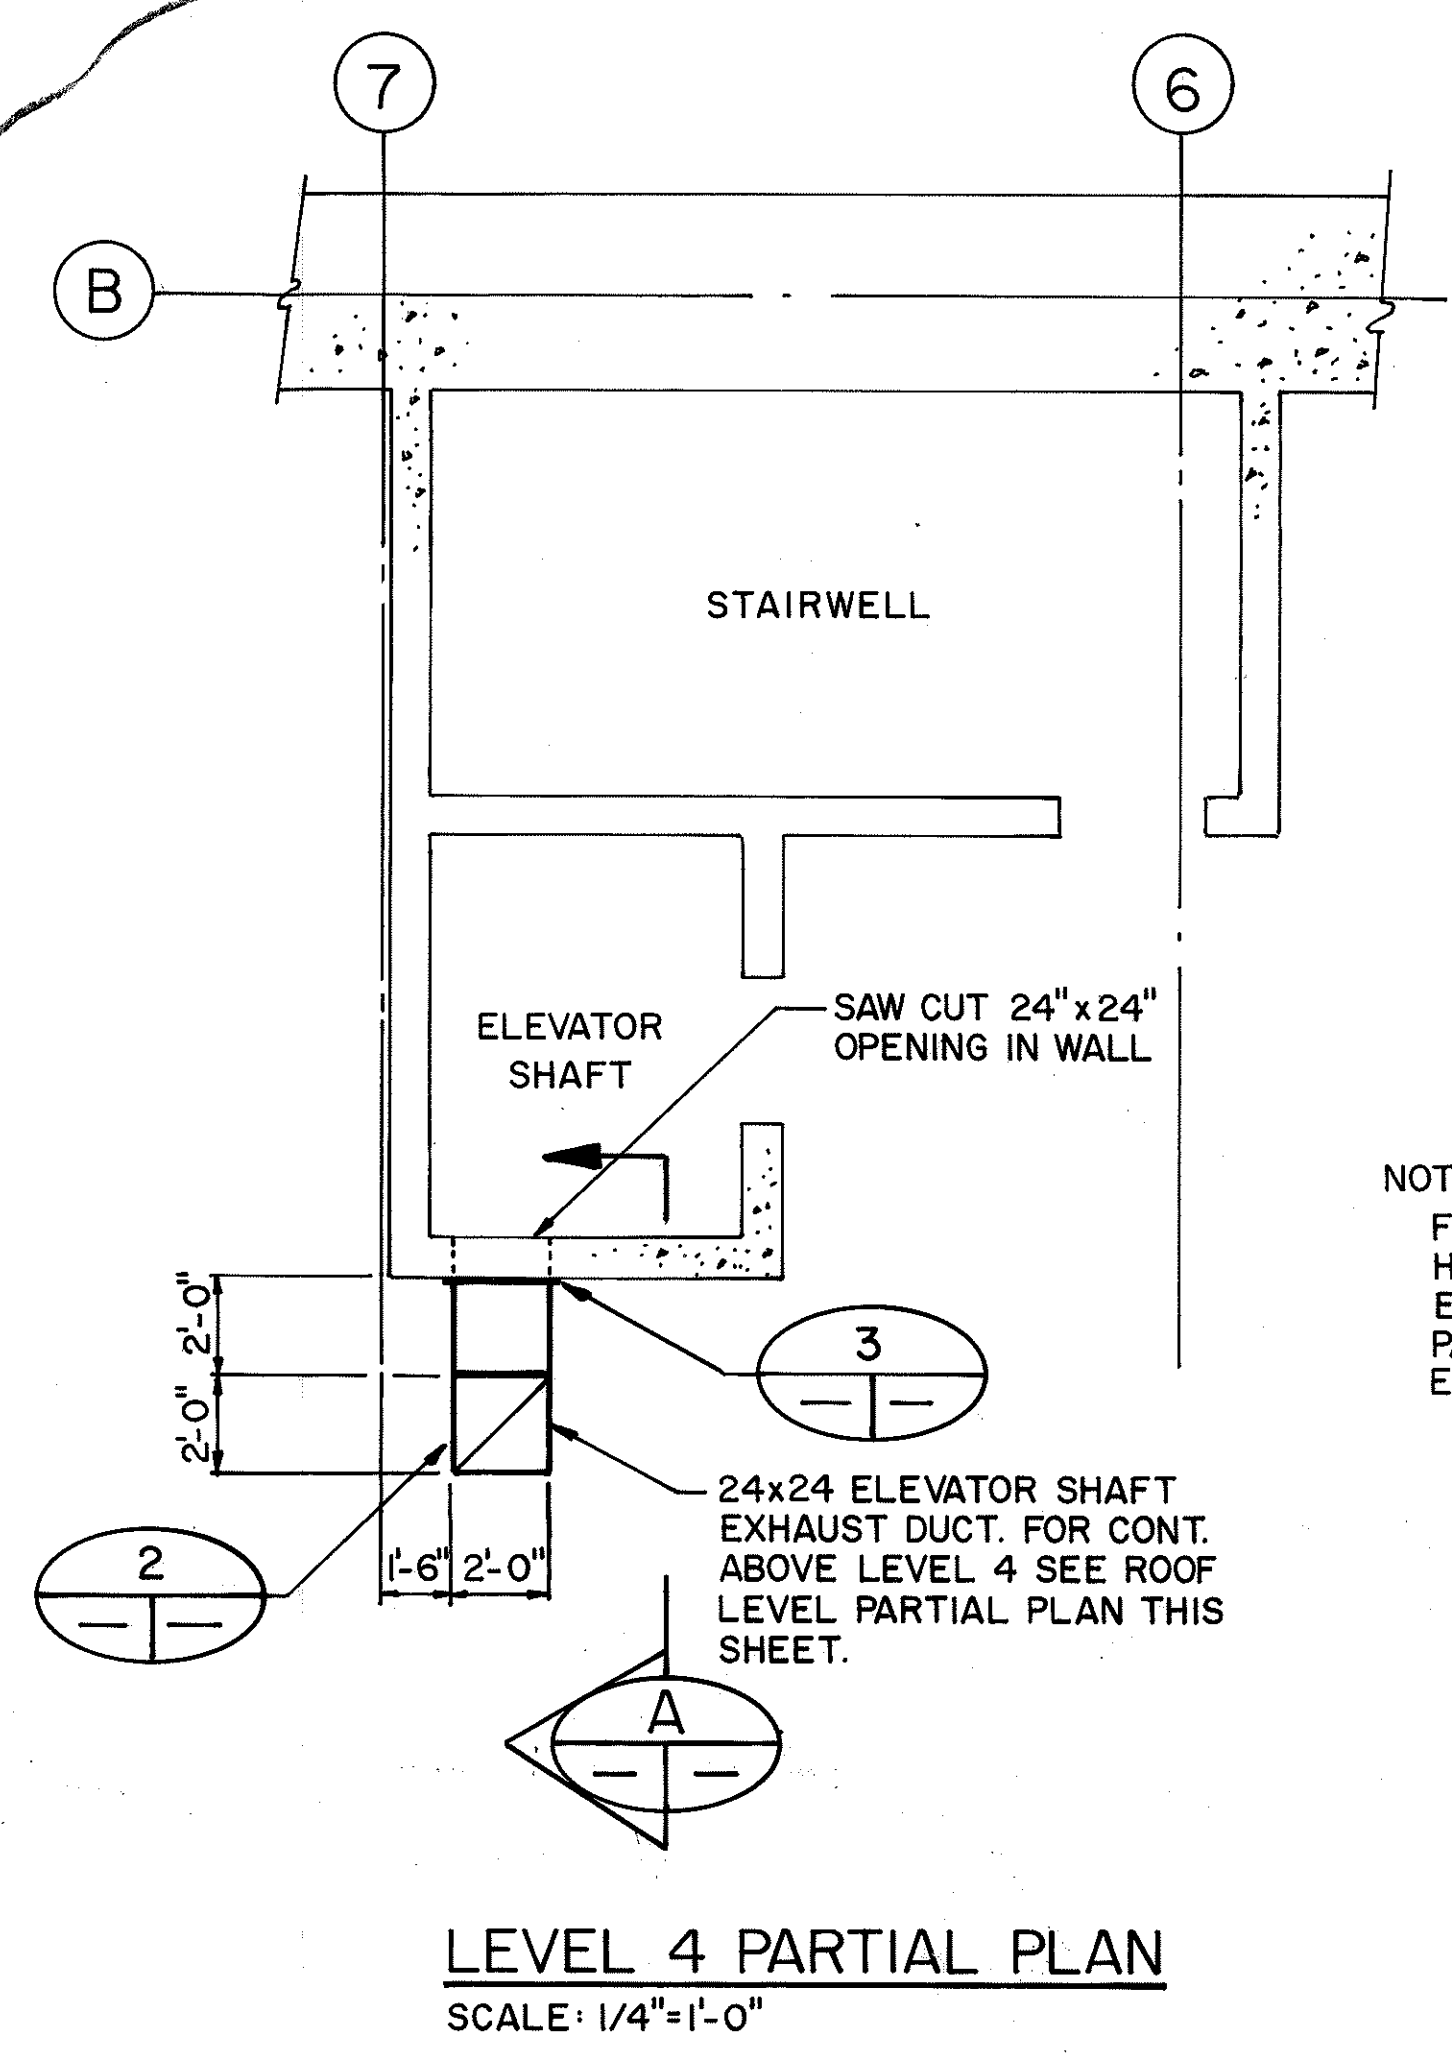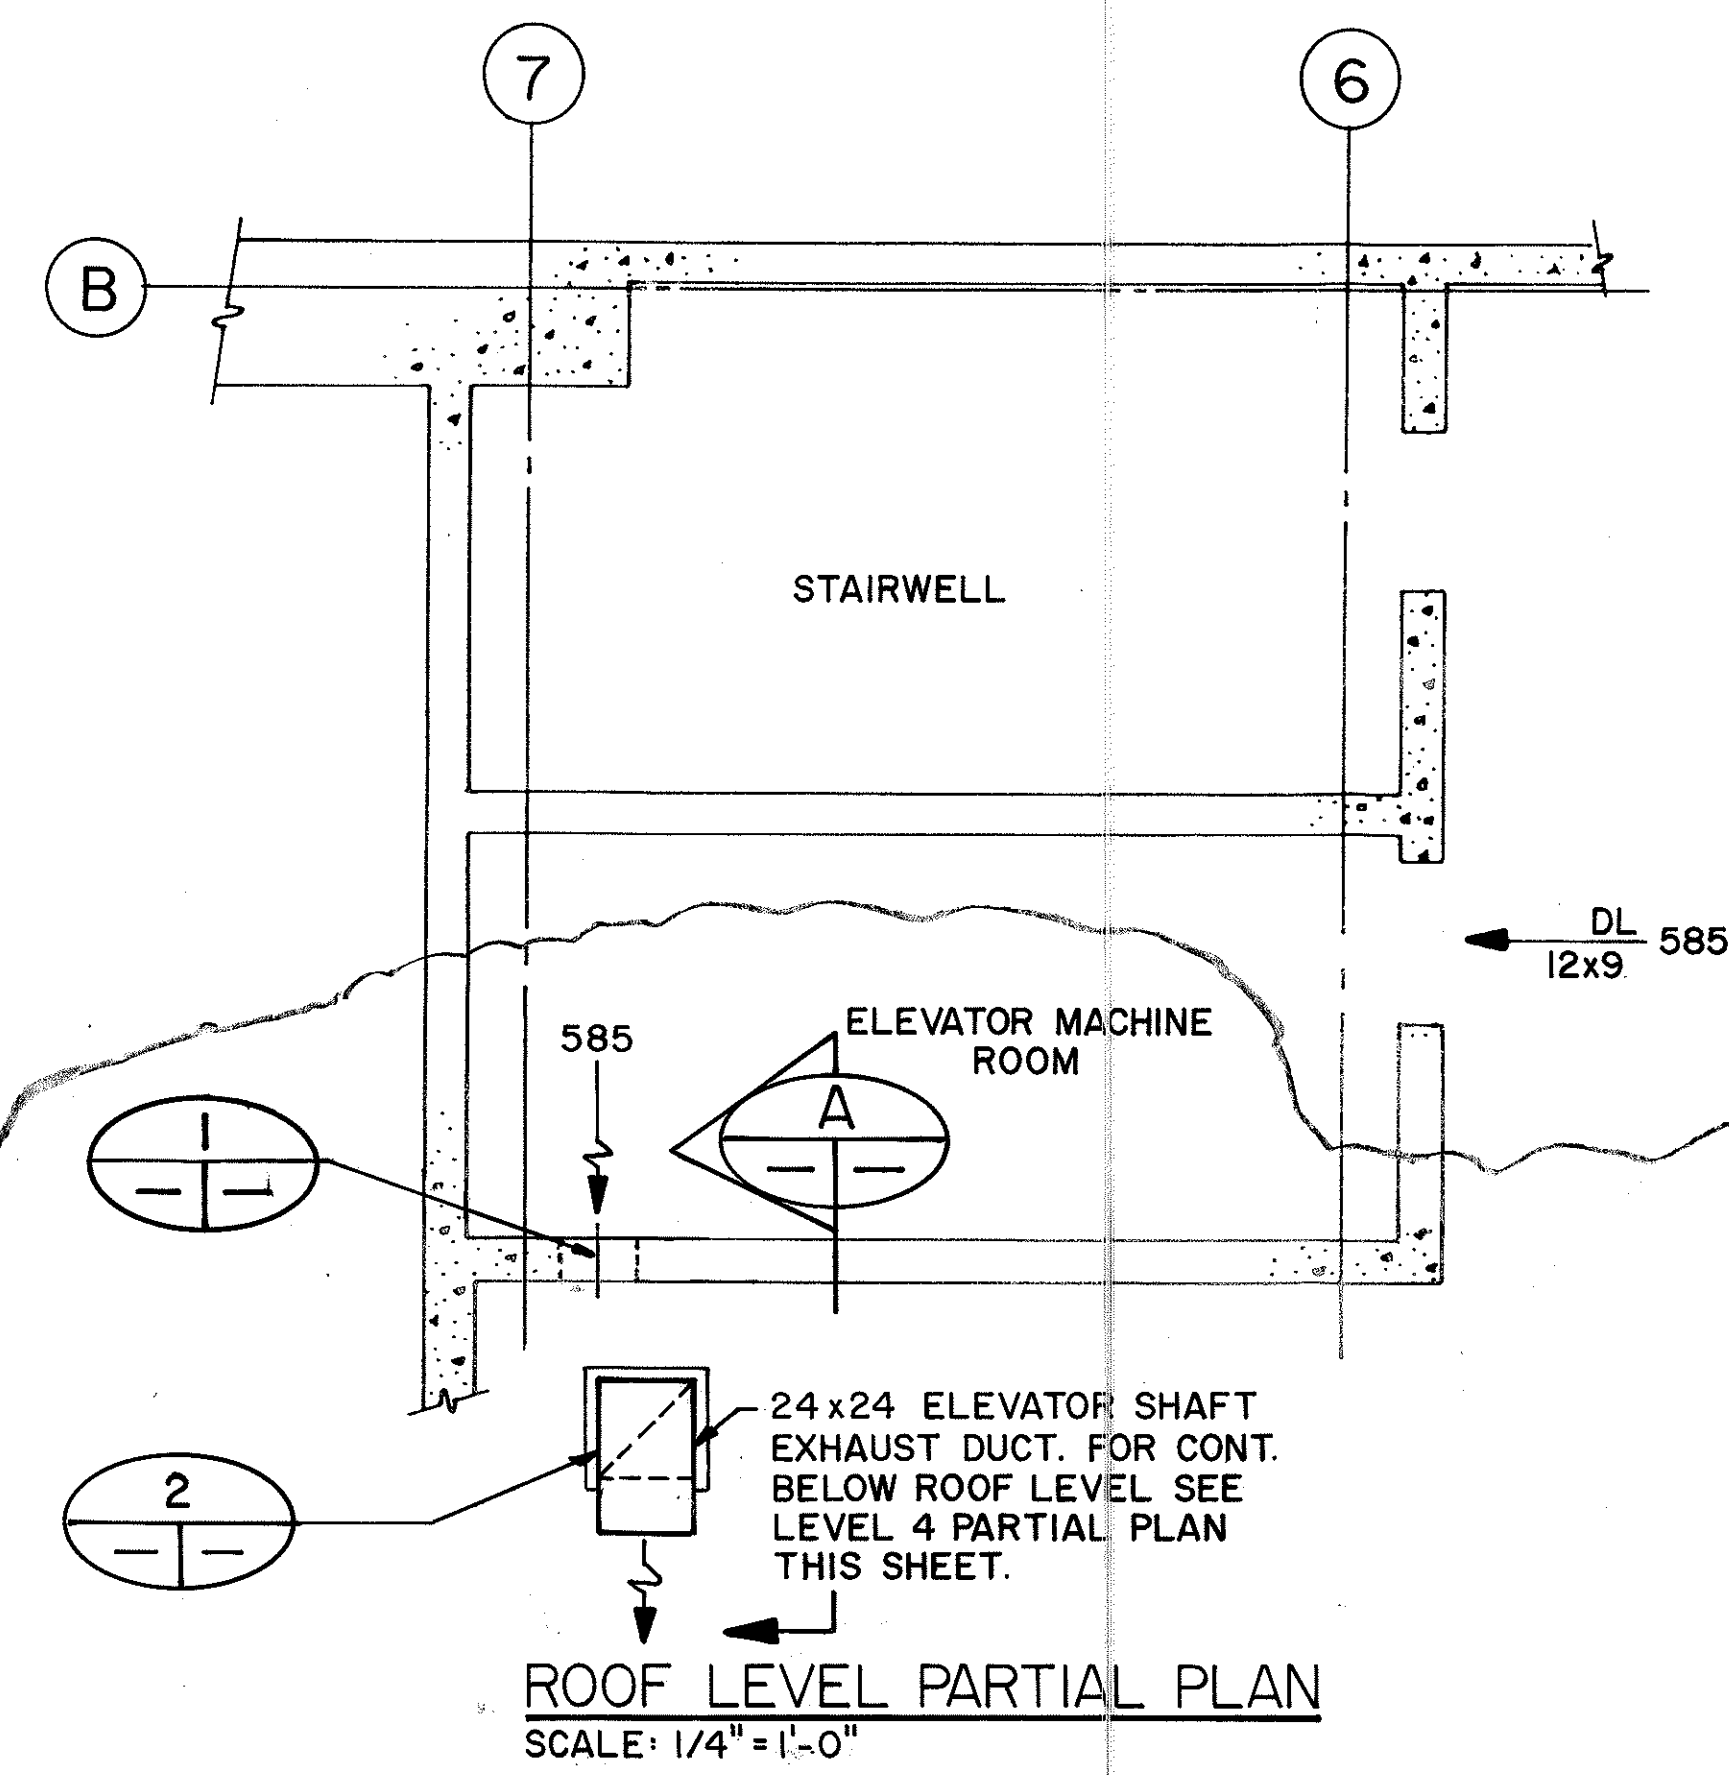



NOTE:
FOR SAW CUT OPENINGS-BUSH HAMMER EXPOSED EDGES TO EVEN SURFACE, GRIND SMOOTH. PAINT EDGES OF OPENINGS AND EXPOSED REBAR WITH EPOXY PAINT.

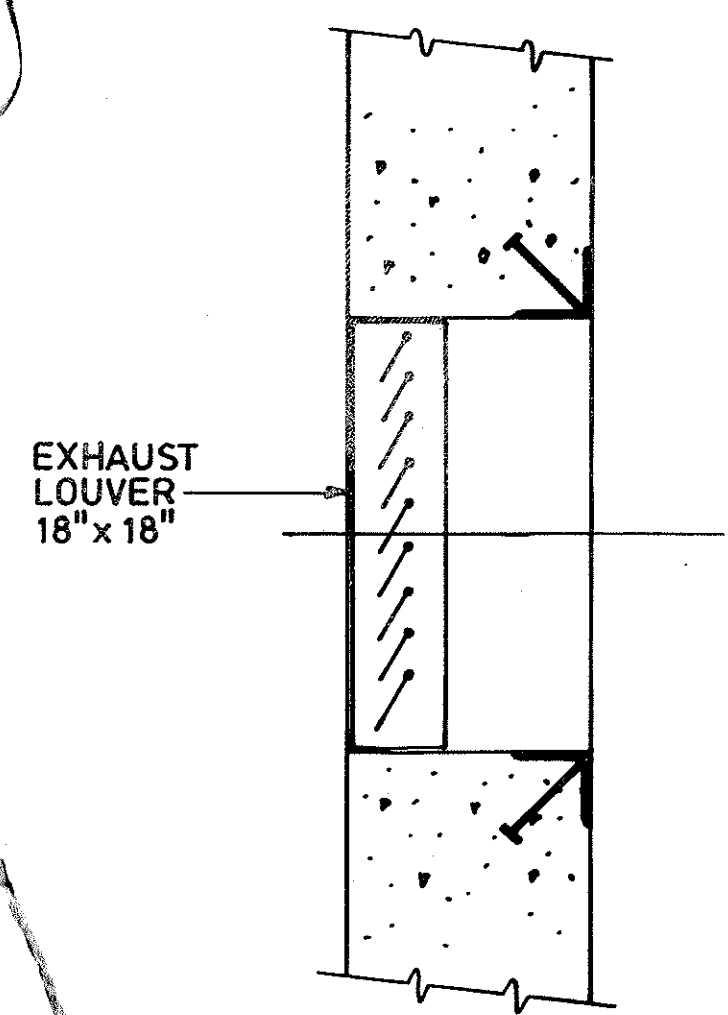

DETAIL
NO SCALE

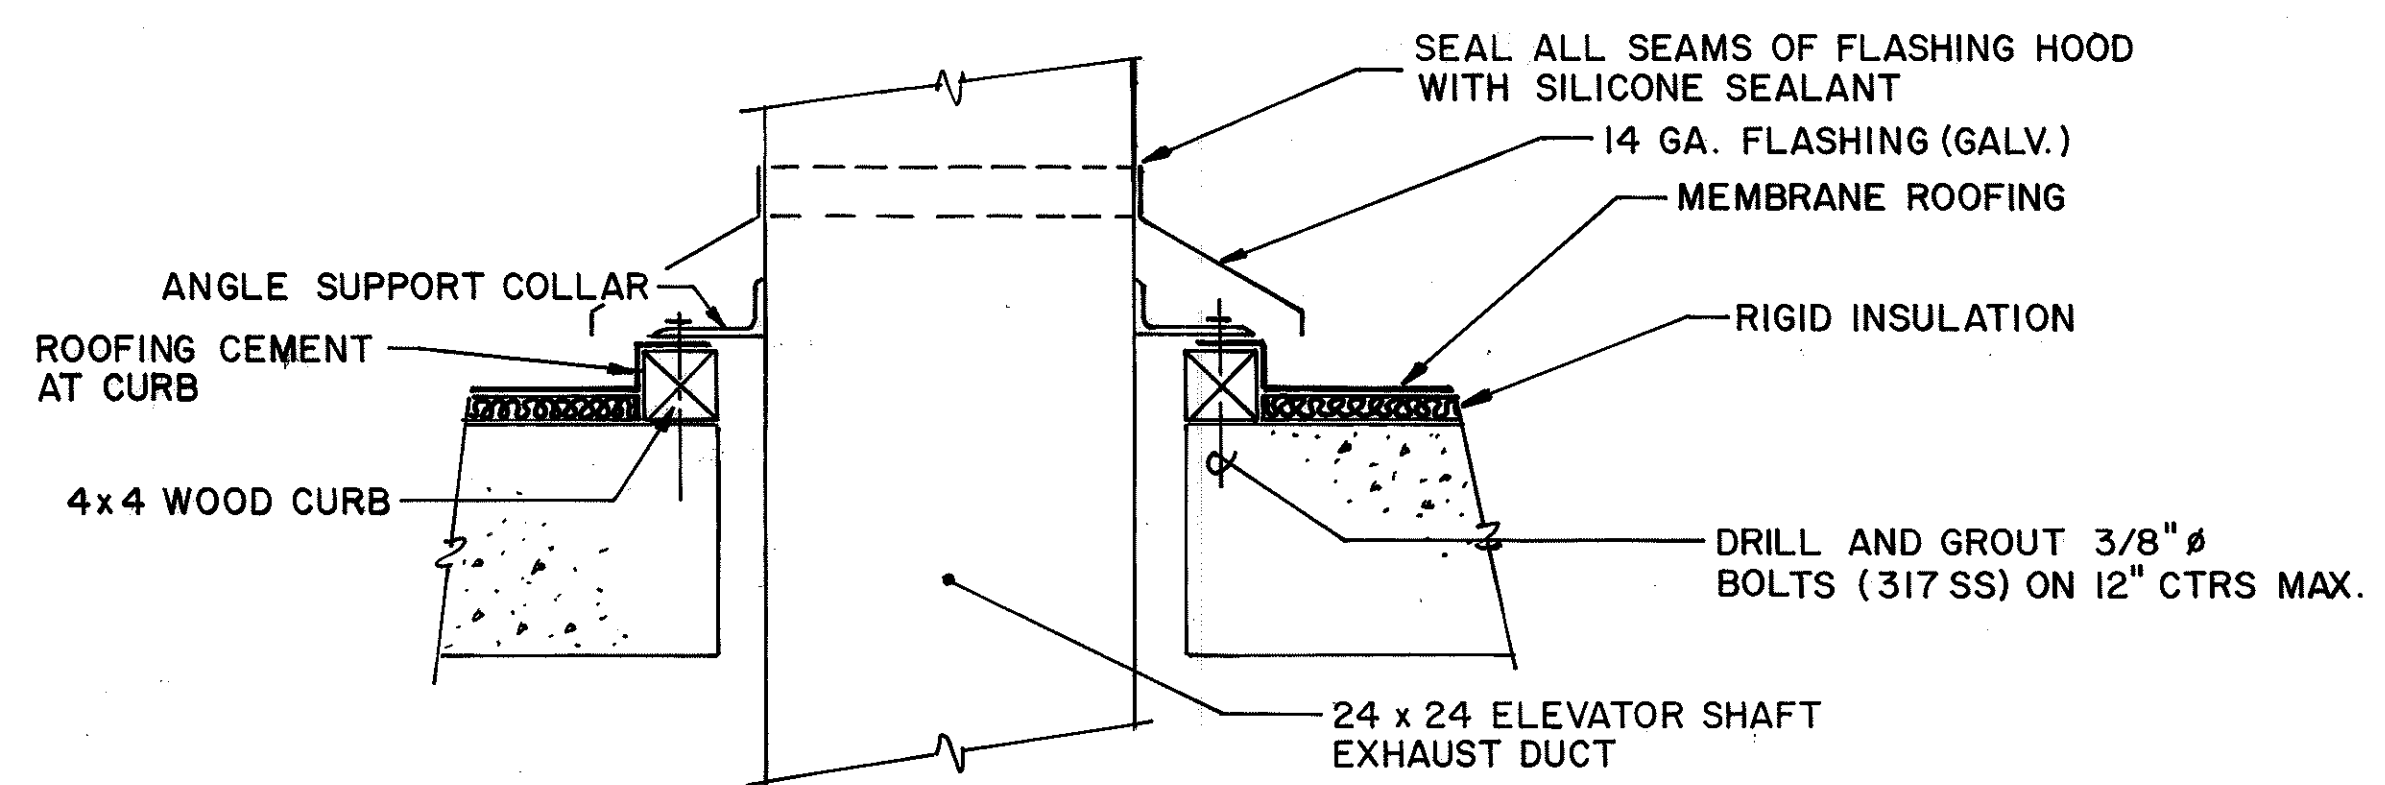

DETAIL 2
NO SCALE
MN3
MM3
MQ3

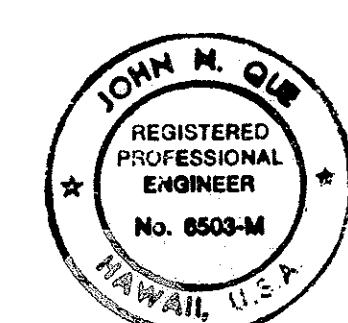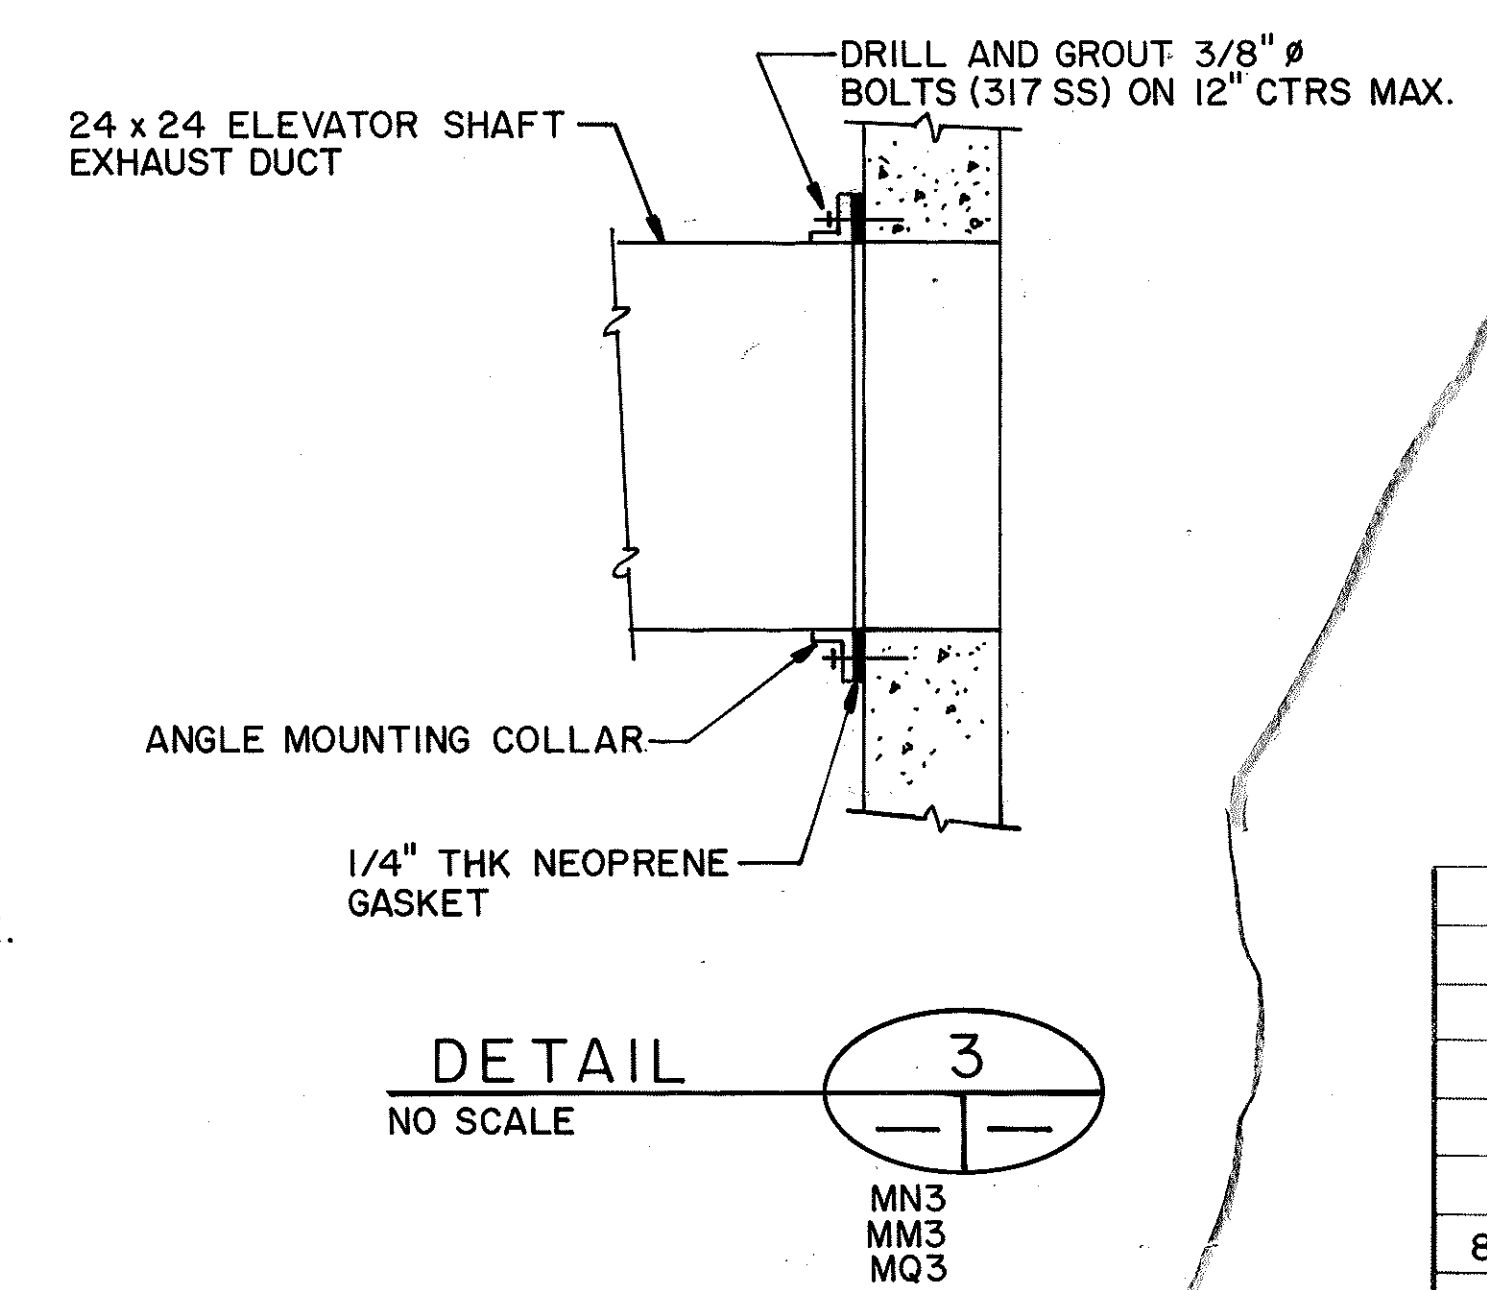


THIS WORK WAS PREPARED BY ME OR UNDER MY SUPERVISION

John M. Qie


8/15/94	REV. PER DCN 66-052
DATE	REVISION
STATE OF HAWAII DEPARTMENT OF TRANSPORTATION HIGHWAYS DIVISION HVAC-ELEVATOR EQUIPMENT ROOM PLAN AND DETAILS HALAWA PORTAL BUILDING-OB INTERSTATE ROUTE H-3 F.A.I. PROJ. NO. I-H3-1(66)	
SCALE: AS NOTED	DATE: APR 1992
SHEET NO. M03 OF 6 SHEETS	

ORIGINAL PLAN	DATE
DESIGNED BY D.E. DRYDEN	12/14/89
CHECKED BY D.E. DRYDEN	12/06/89
NOTED BY J.N. QUE	06/05/90


FED. ROAD DIST. NO.	STATE	FED. AID PROJ. NO.	FISCAL YEAR	SHEET NO.	TOTAL SHEETS
HAWAII	HAW.	I - H3 - 1(66)	1992	52	440

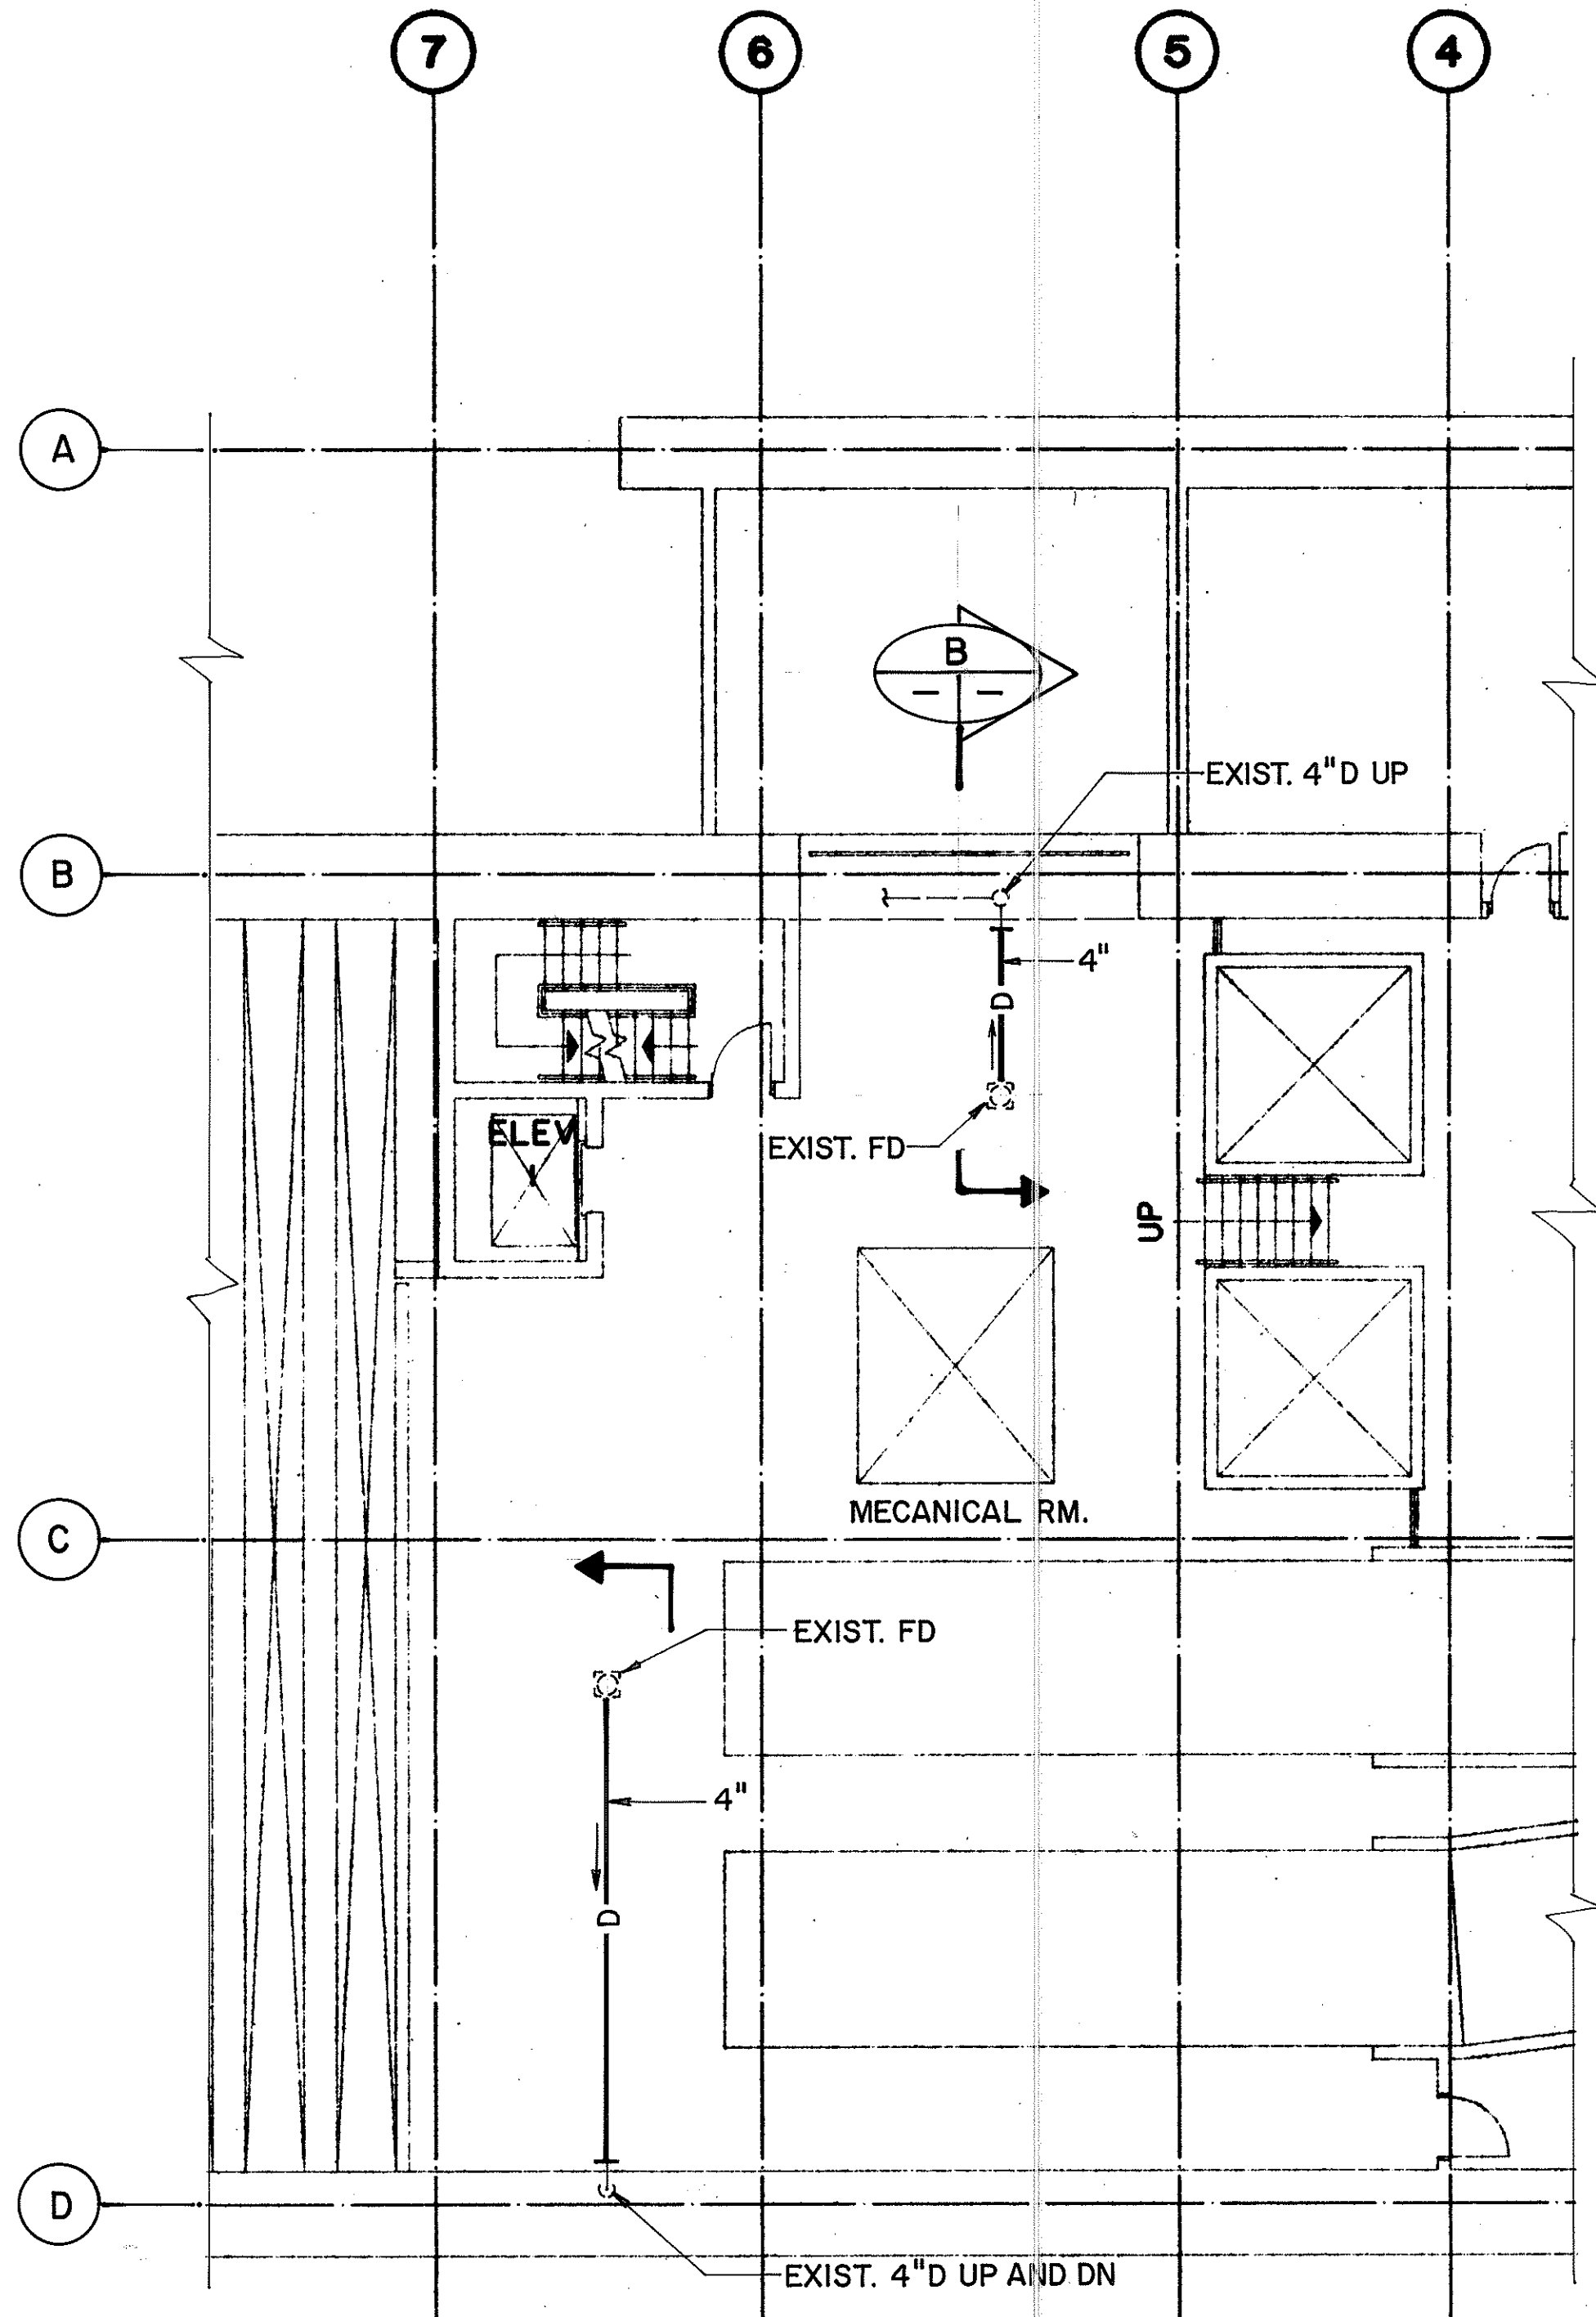

LEVEL 3 PARTIAL PLAN
SCALE: 1/8" = 1'-0"

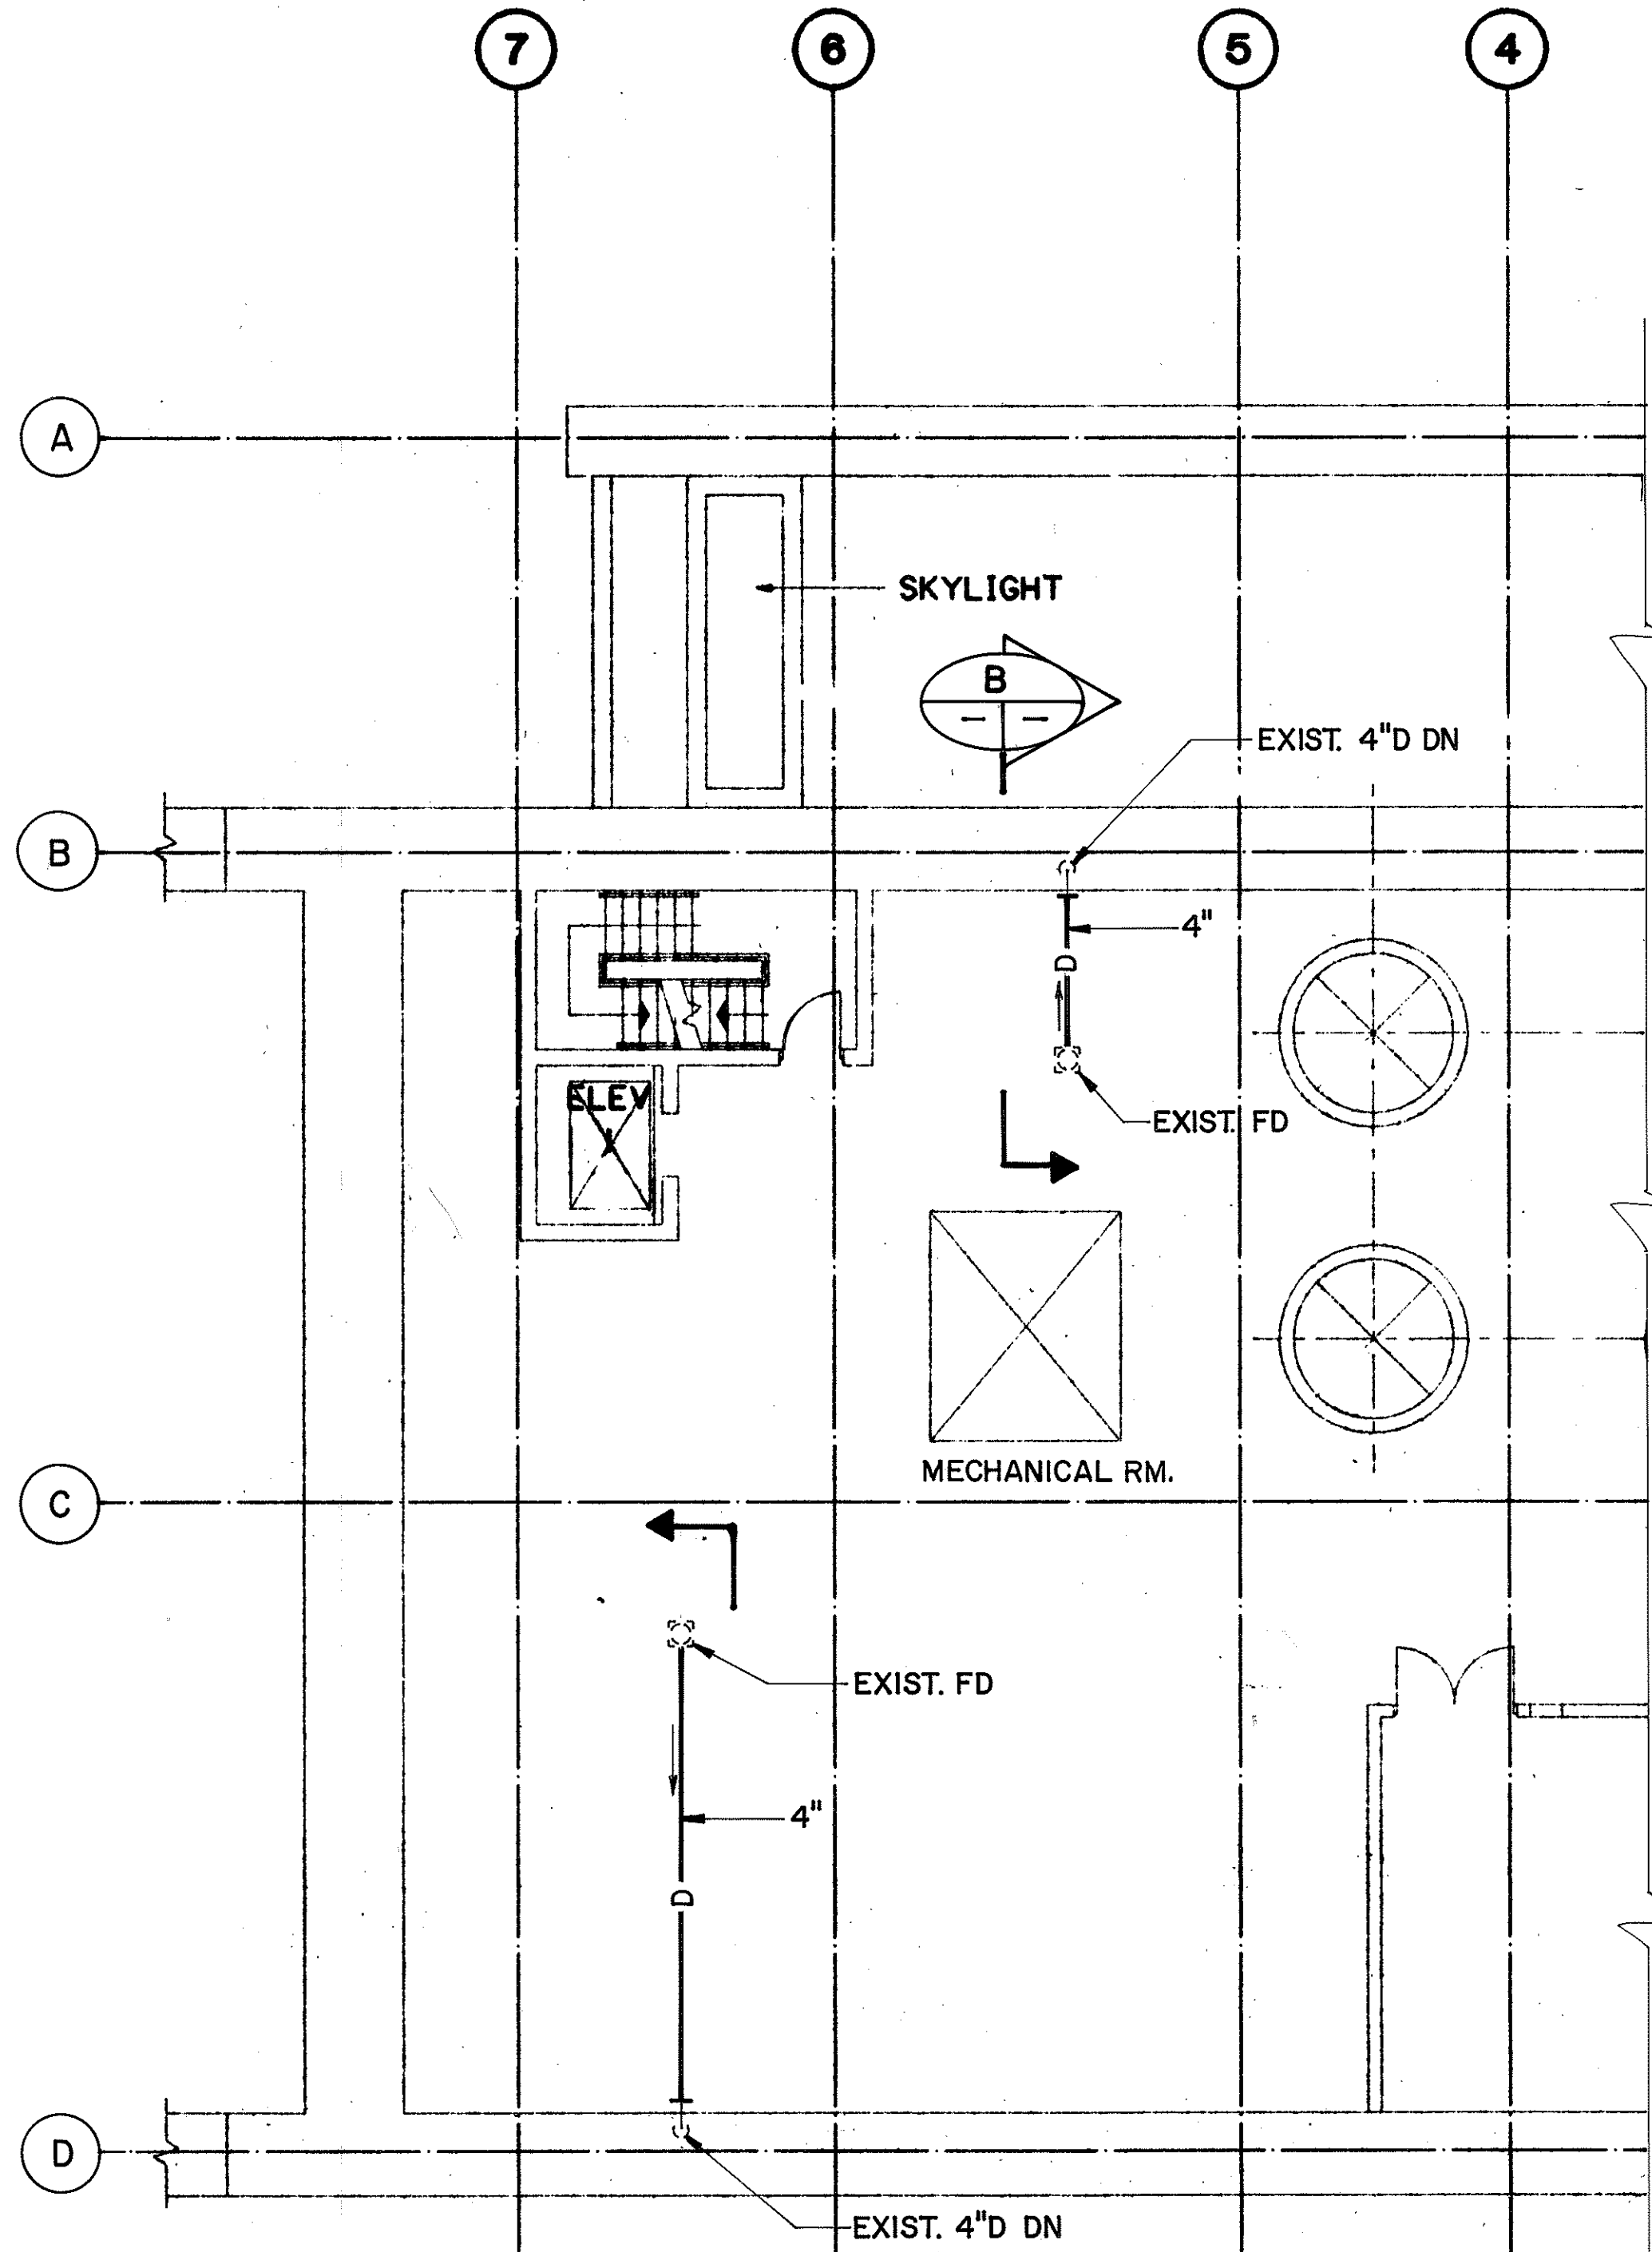

LEVEL 4 PARTIAL PLAN
SCALE: 1/8" = 1'-0"

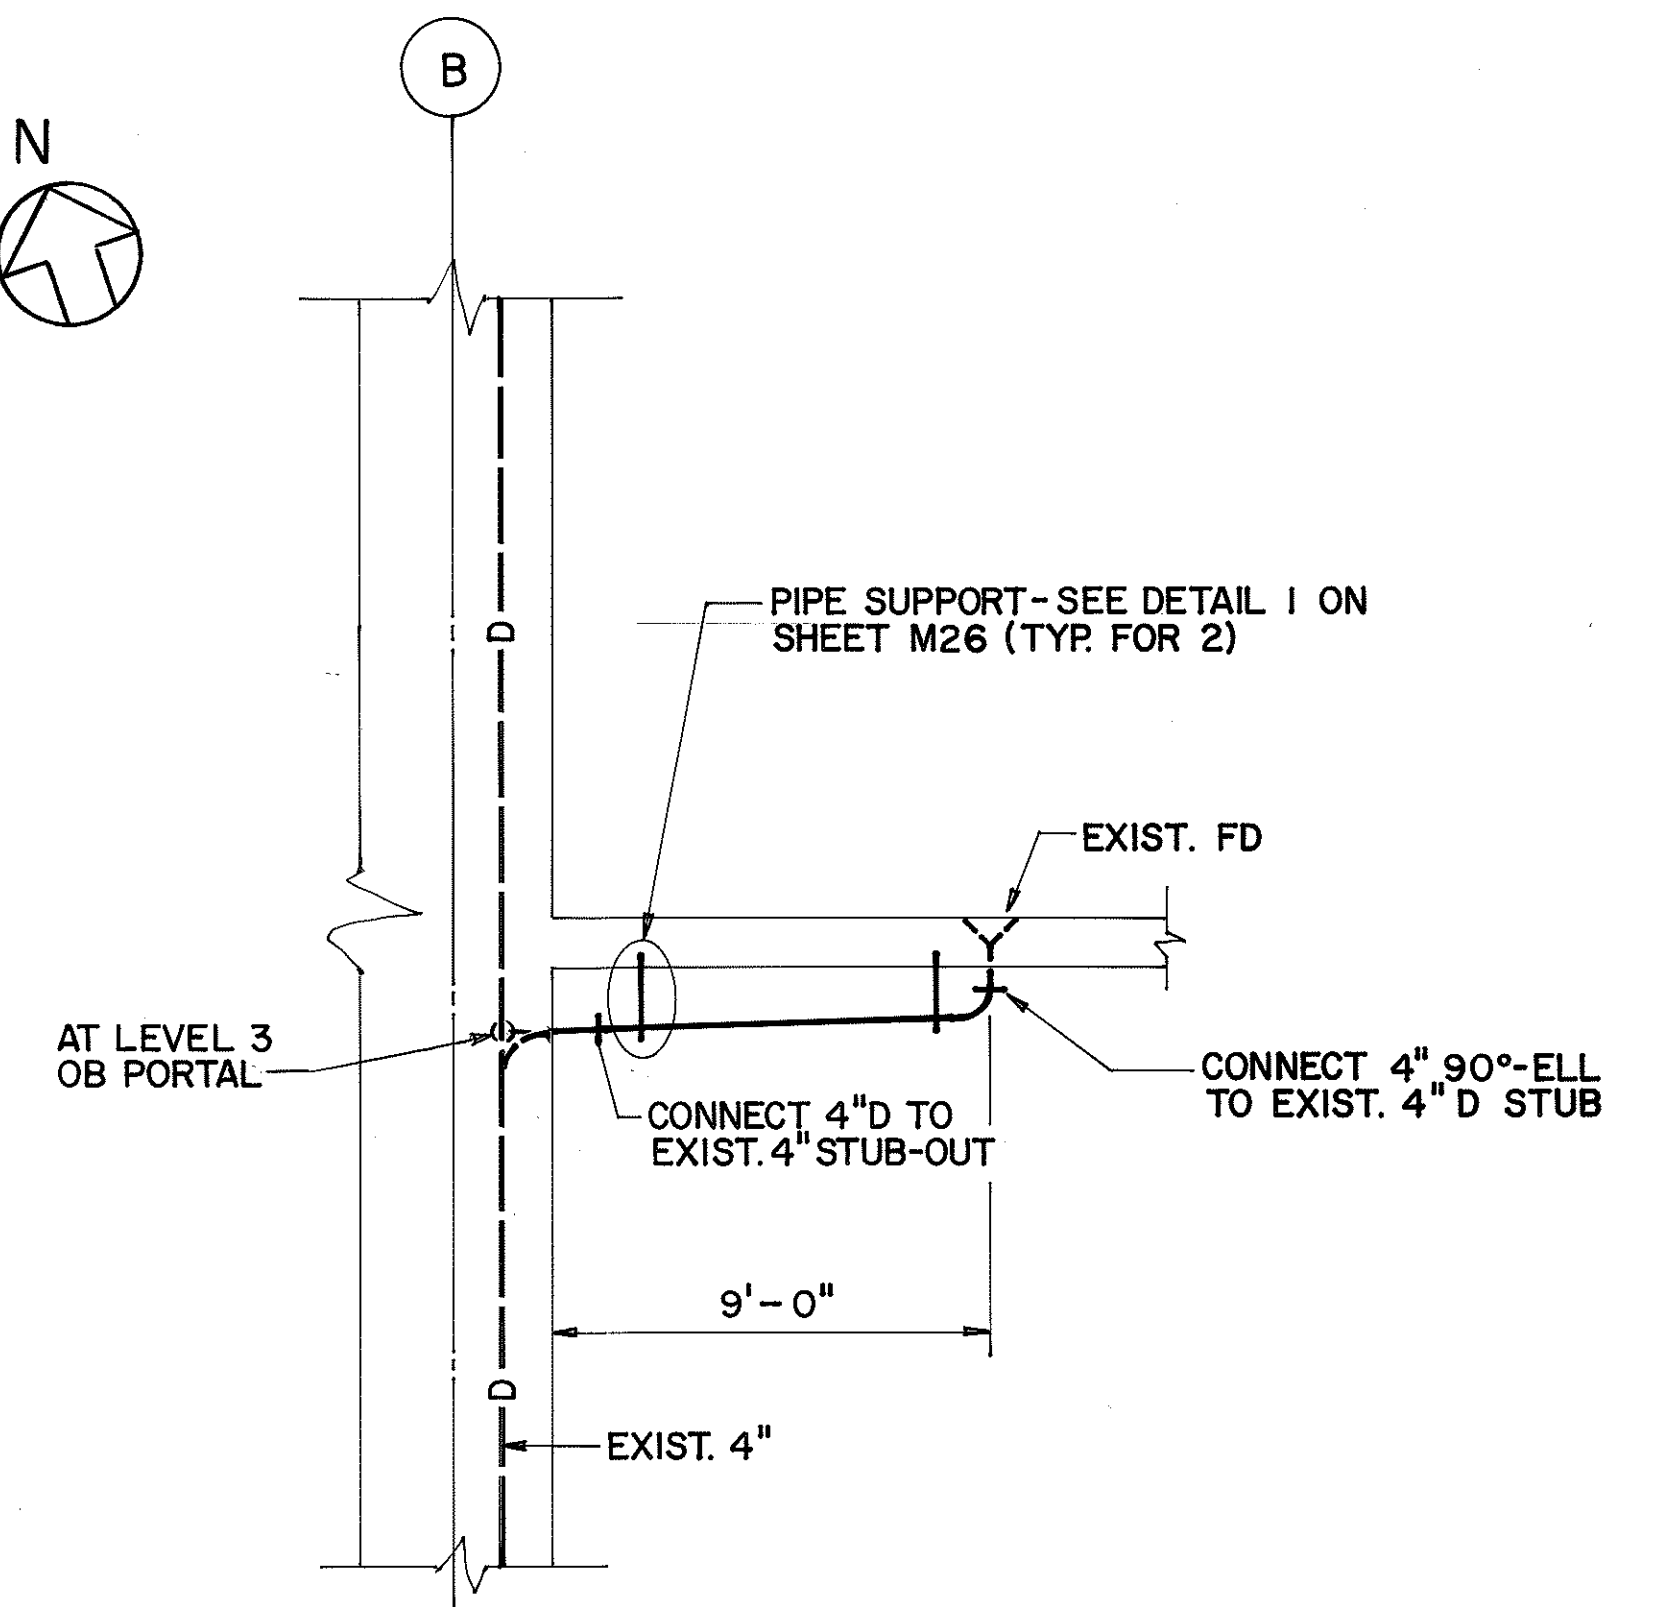

SECTION

SCALE: 1/4" = 1' - 0"

B

MO4
MN4

MO4

**FOR DETAIL AS-BUILT INFORMATION
REFER TO CONSTRUCTION SUBMITTALS**


DATE	REVISION

STATE OF HAWAII
DEPARTMENT OF TRANSPORTATION
HIGHWAYS DIVISION

PLUMBING - LEVEL 3 & LEVEL 4 PARTIAL PLANS

HALAWA PORTAL BUILDING - OB
INTERSTATE ROUTE H-3
F.A.I. PROJ. NO. I-H3-1 (66)

SCALE : AS NOTED DATE : APR 1992
SHEET NO. M04 OF 6 SHEETS

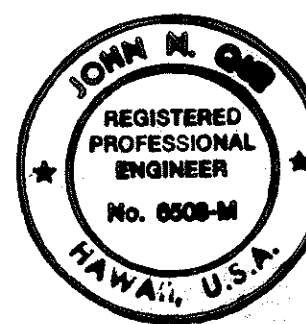


THIS WORK WAS PREPARED BY ME
OR UNDER MY SUPERVISION


John Doe

ORIGINAL PLAN	SURVEY PLOTTED BY B. F. BUNYI, JR.	DATE 12/3/89
NOTE BOOK	TRACED BY _____	
	DESIGNED BY P. L. LALQUE	12/5/89
	QUANTITIES BY _____	
NO. _____	CHECKED BY J. N. QUE	06/05/90

FED. ROAD DIST. NO.	STATE	FED. AID PROJ. NO.	FISCAL YEAR	SHEET NO.	TOTAL SHEETS
HAWAII	HAW.	I - H3 - 1(66)	1992	53	440

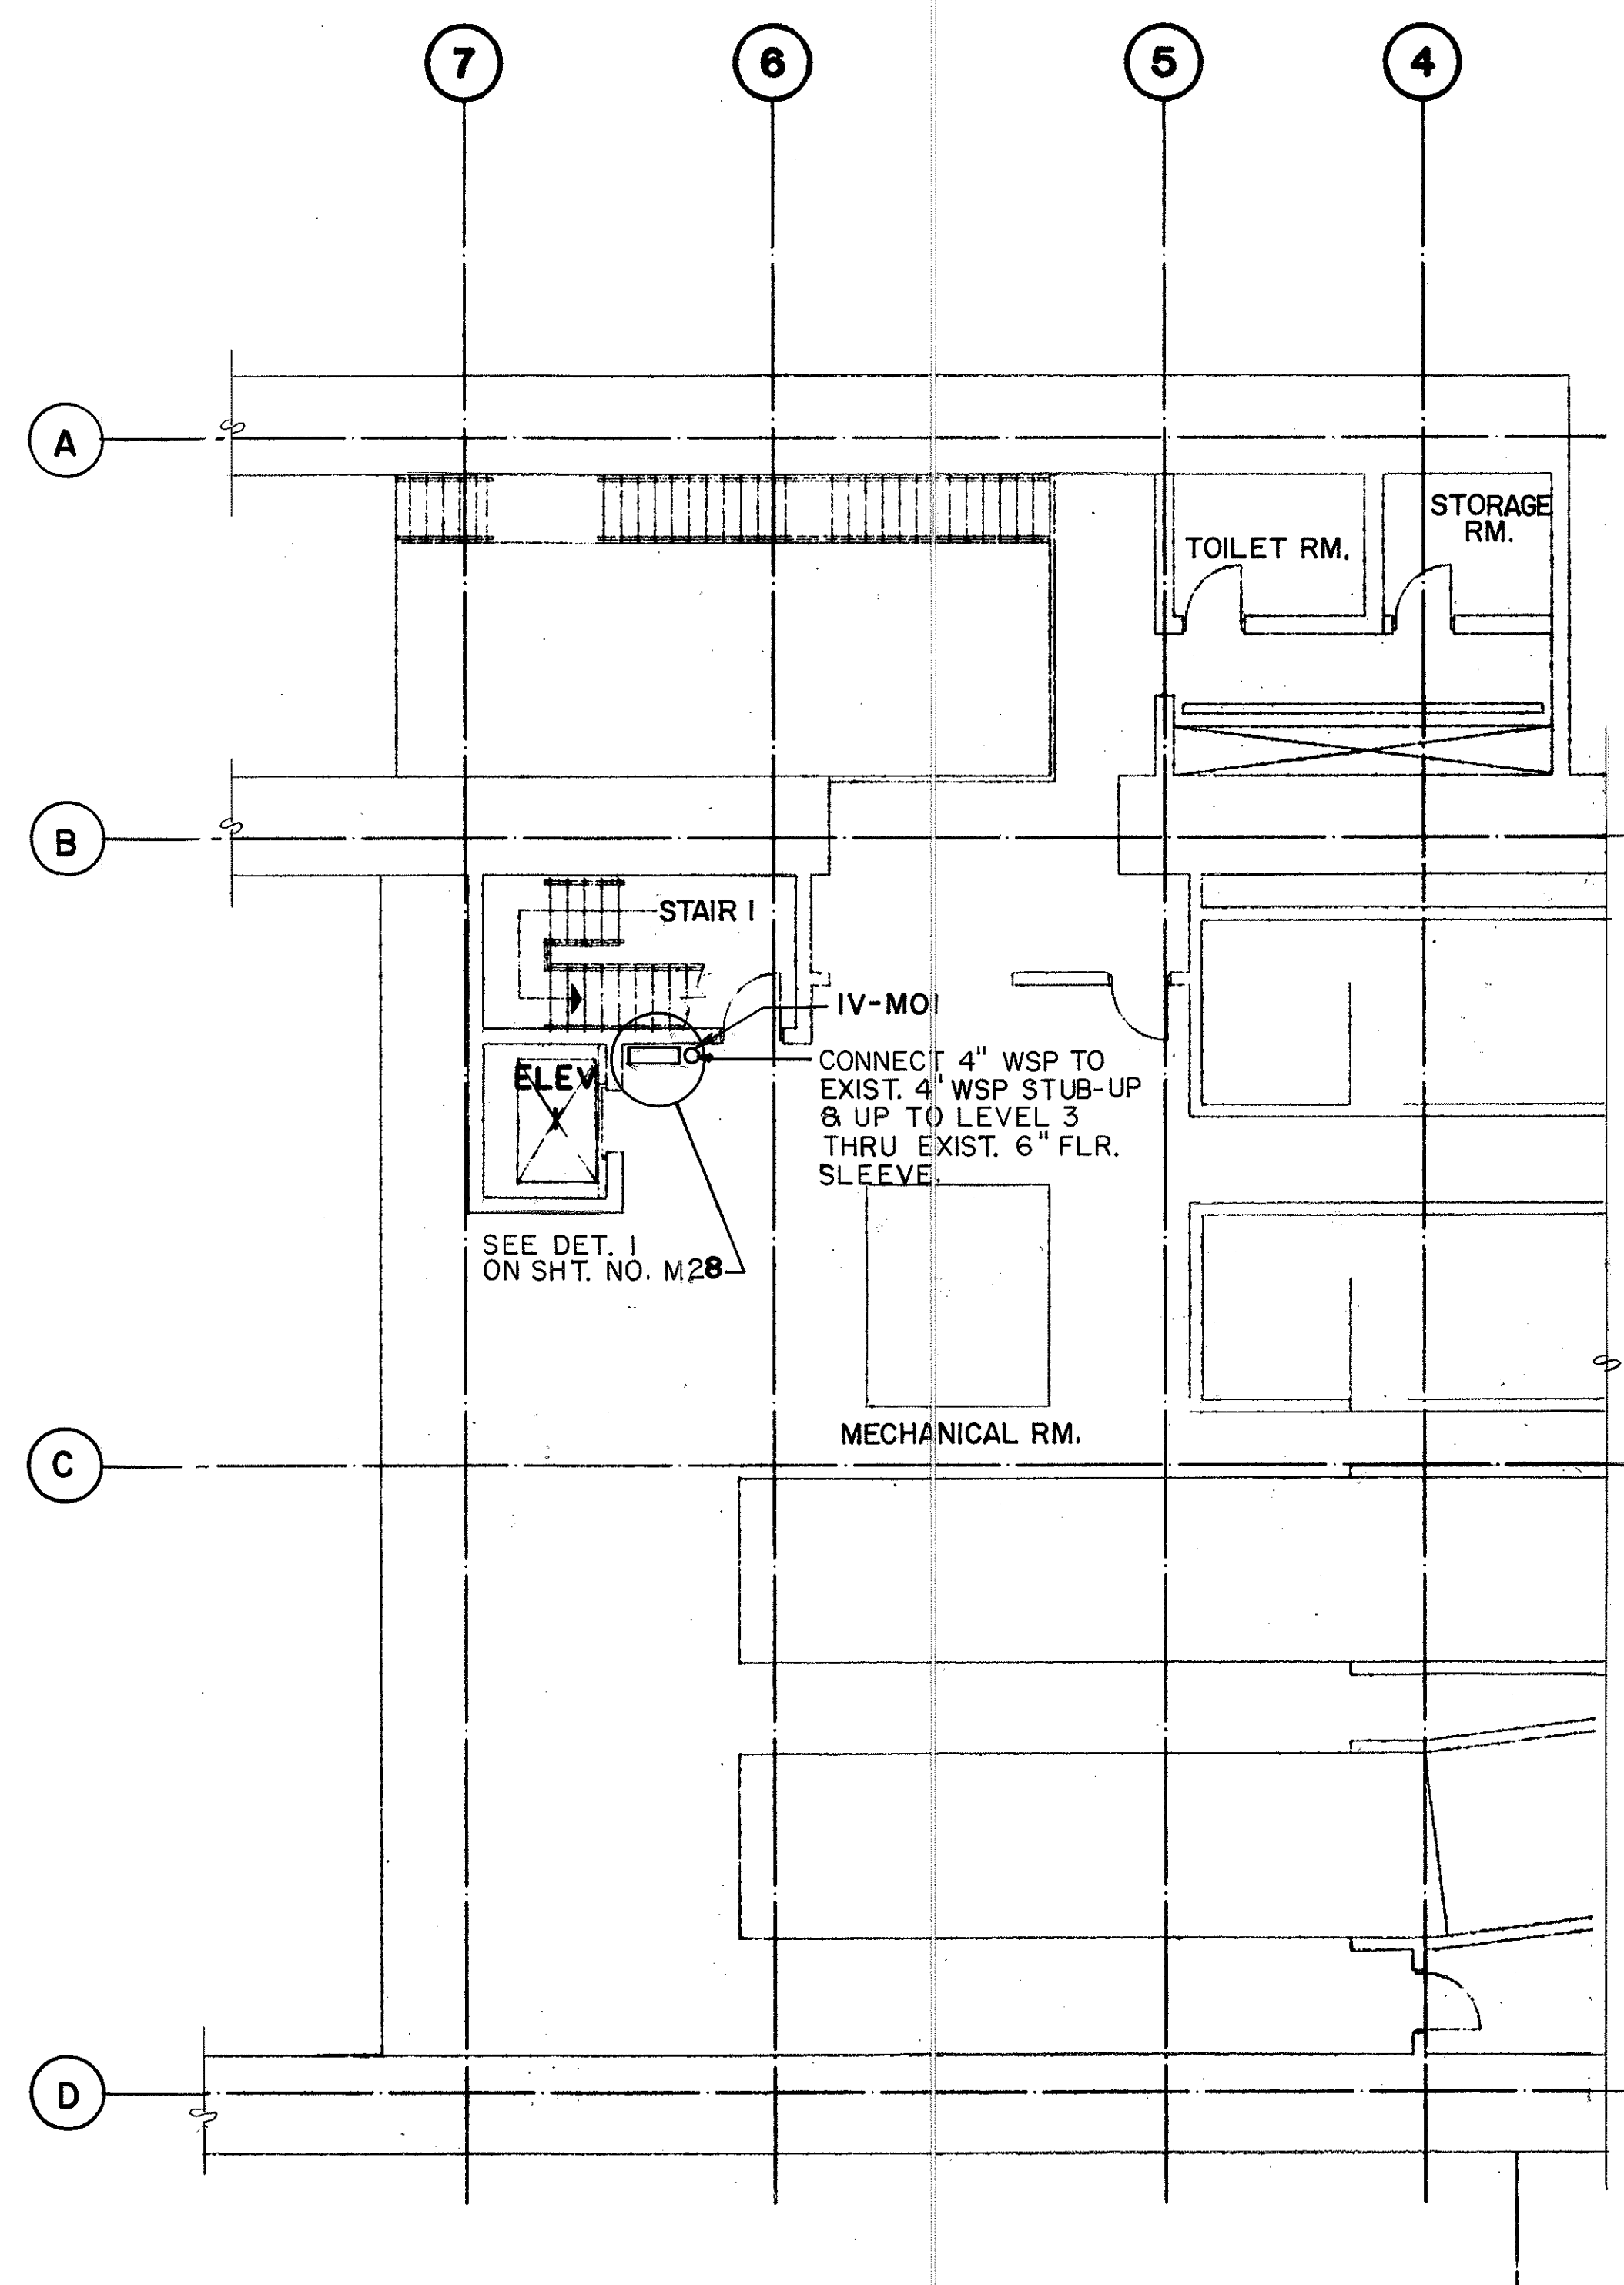

LEVEL 2

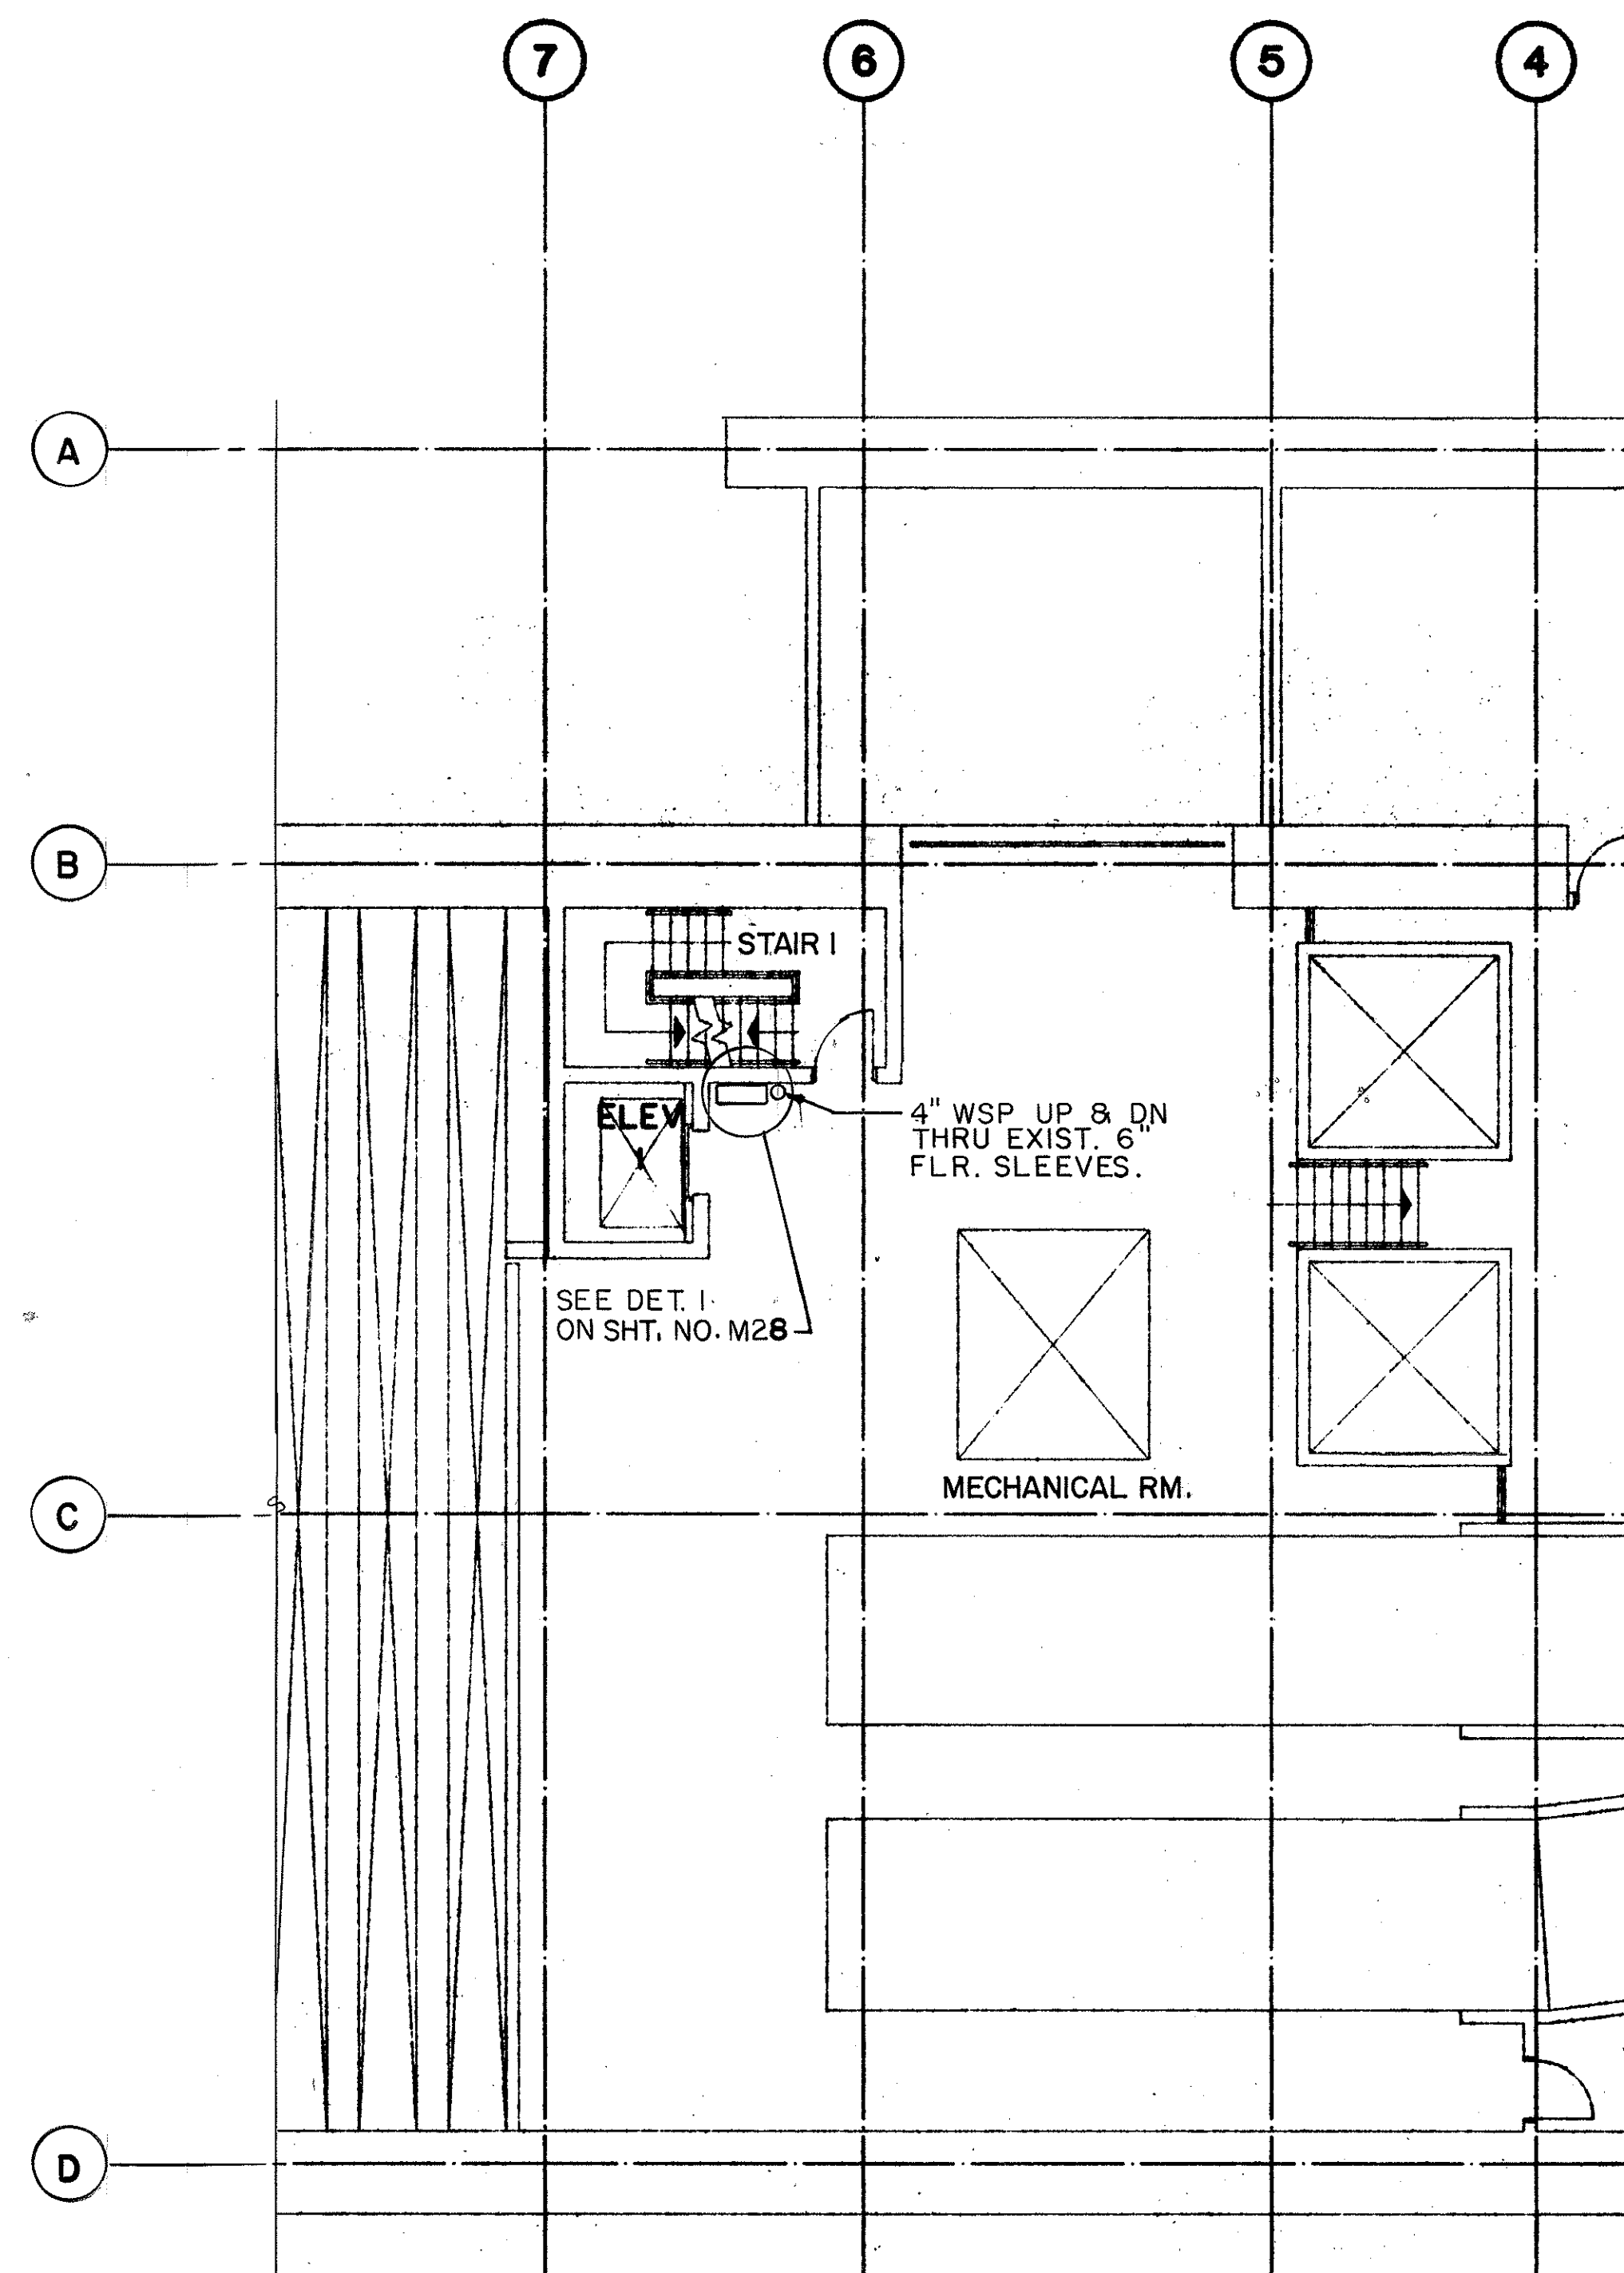

LEVEL 3



ORIGINAL PLAN	SURVEY PLOTTED BY	DATE
	DRAWN BY <u>P. L. LALOUE</u>	<u>2/5/89</u>
	TRACED BY _____	
	DESIGNED BY <u>P. L. LALOUE</u>	<u>1/30/89</u>
	QUANTITIES BY _____	
	CHECKED BY <u>J. N. QUE</u>	<u>06/04/90</u>
NO.		

FOR DETAIL AS-BUILT INFORMATION
REFER TO CONSTRUCTION SUBMITTALS

[illegible]

STATE OF HAWAII
DEPARTMENT OF TRANSPORTATION
HIGHWAYS DIVISION

FIRE PROTECTION-LEVEL 2 &
LEVEL 3 PARTIAL PLANS
HALAWA PORTAL BUILDING - OB
INTERSTATE ROUTE H-3
F.A.I. PROJ. NO. I-H3-I (66)


SCALE: 1/8" = 1'-0" DATE: APR 1992

SHEET NO. M05 OF 6 SHEETS




THIS WORK WAS PREPARED BY ME
OR UNDER MY SUPERVISION


John D. ...

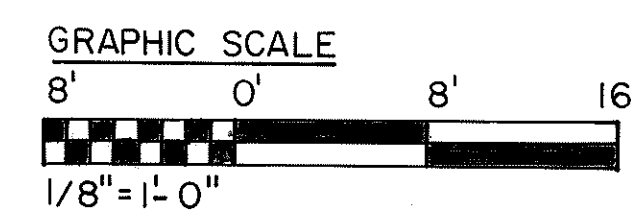



FED. ROAD DIST. NO.	STATE	FED. AID PROJ. NO.	FISCAL YEAR	SHEET NO.	TOTAL SHEETS
HAWAII	HAW.	I-H3-1(66)	1992	54	440

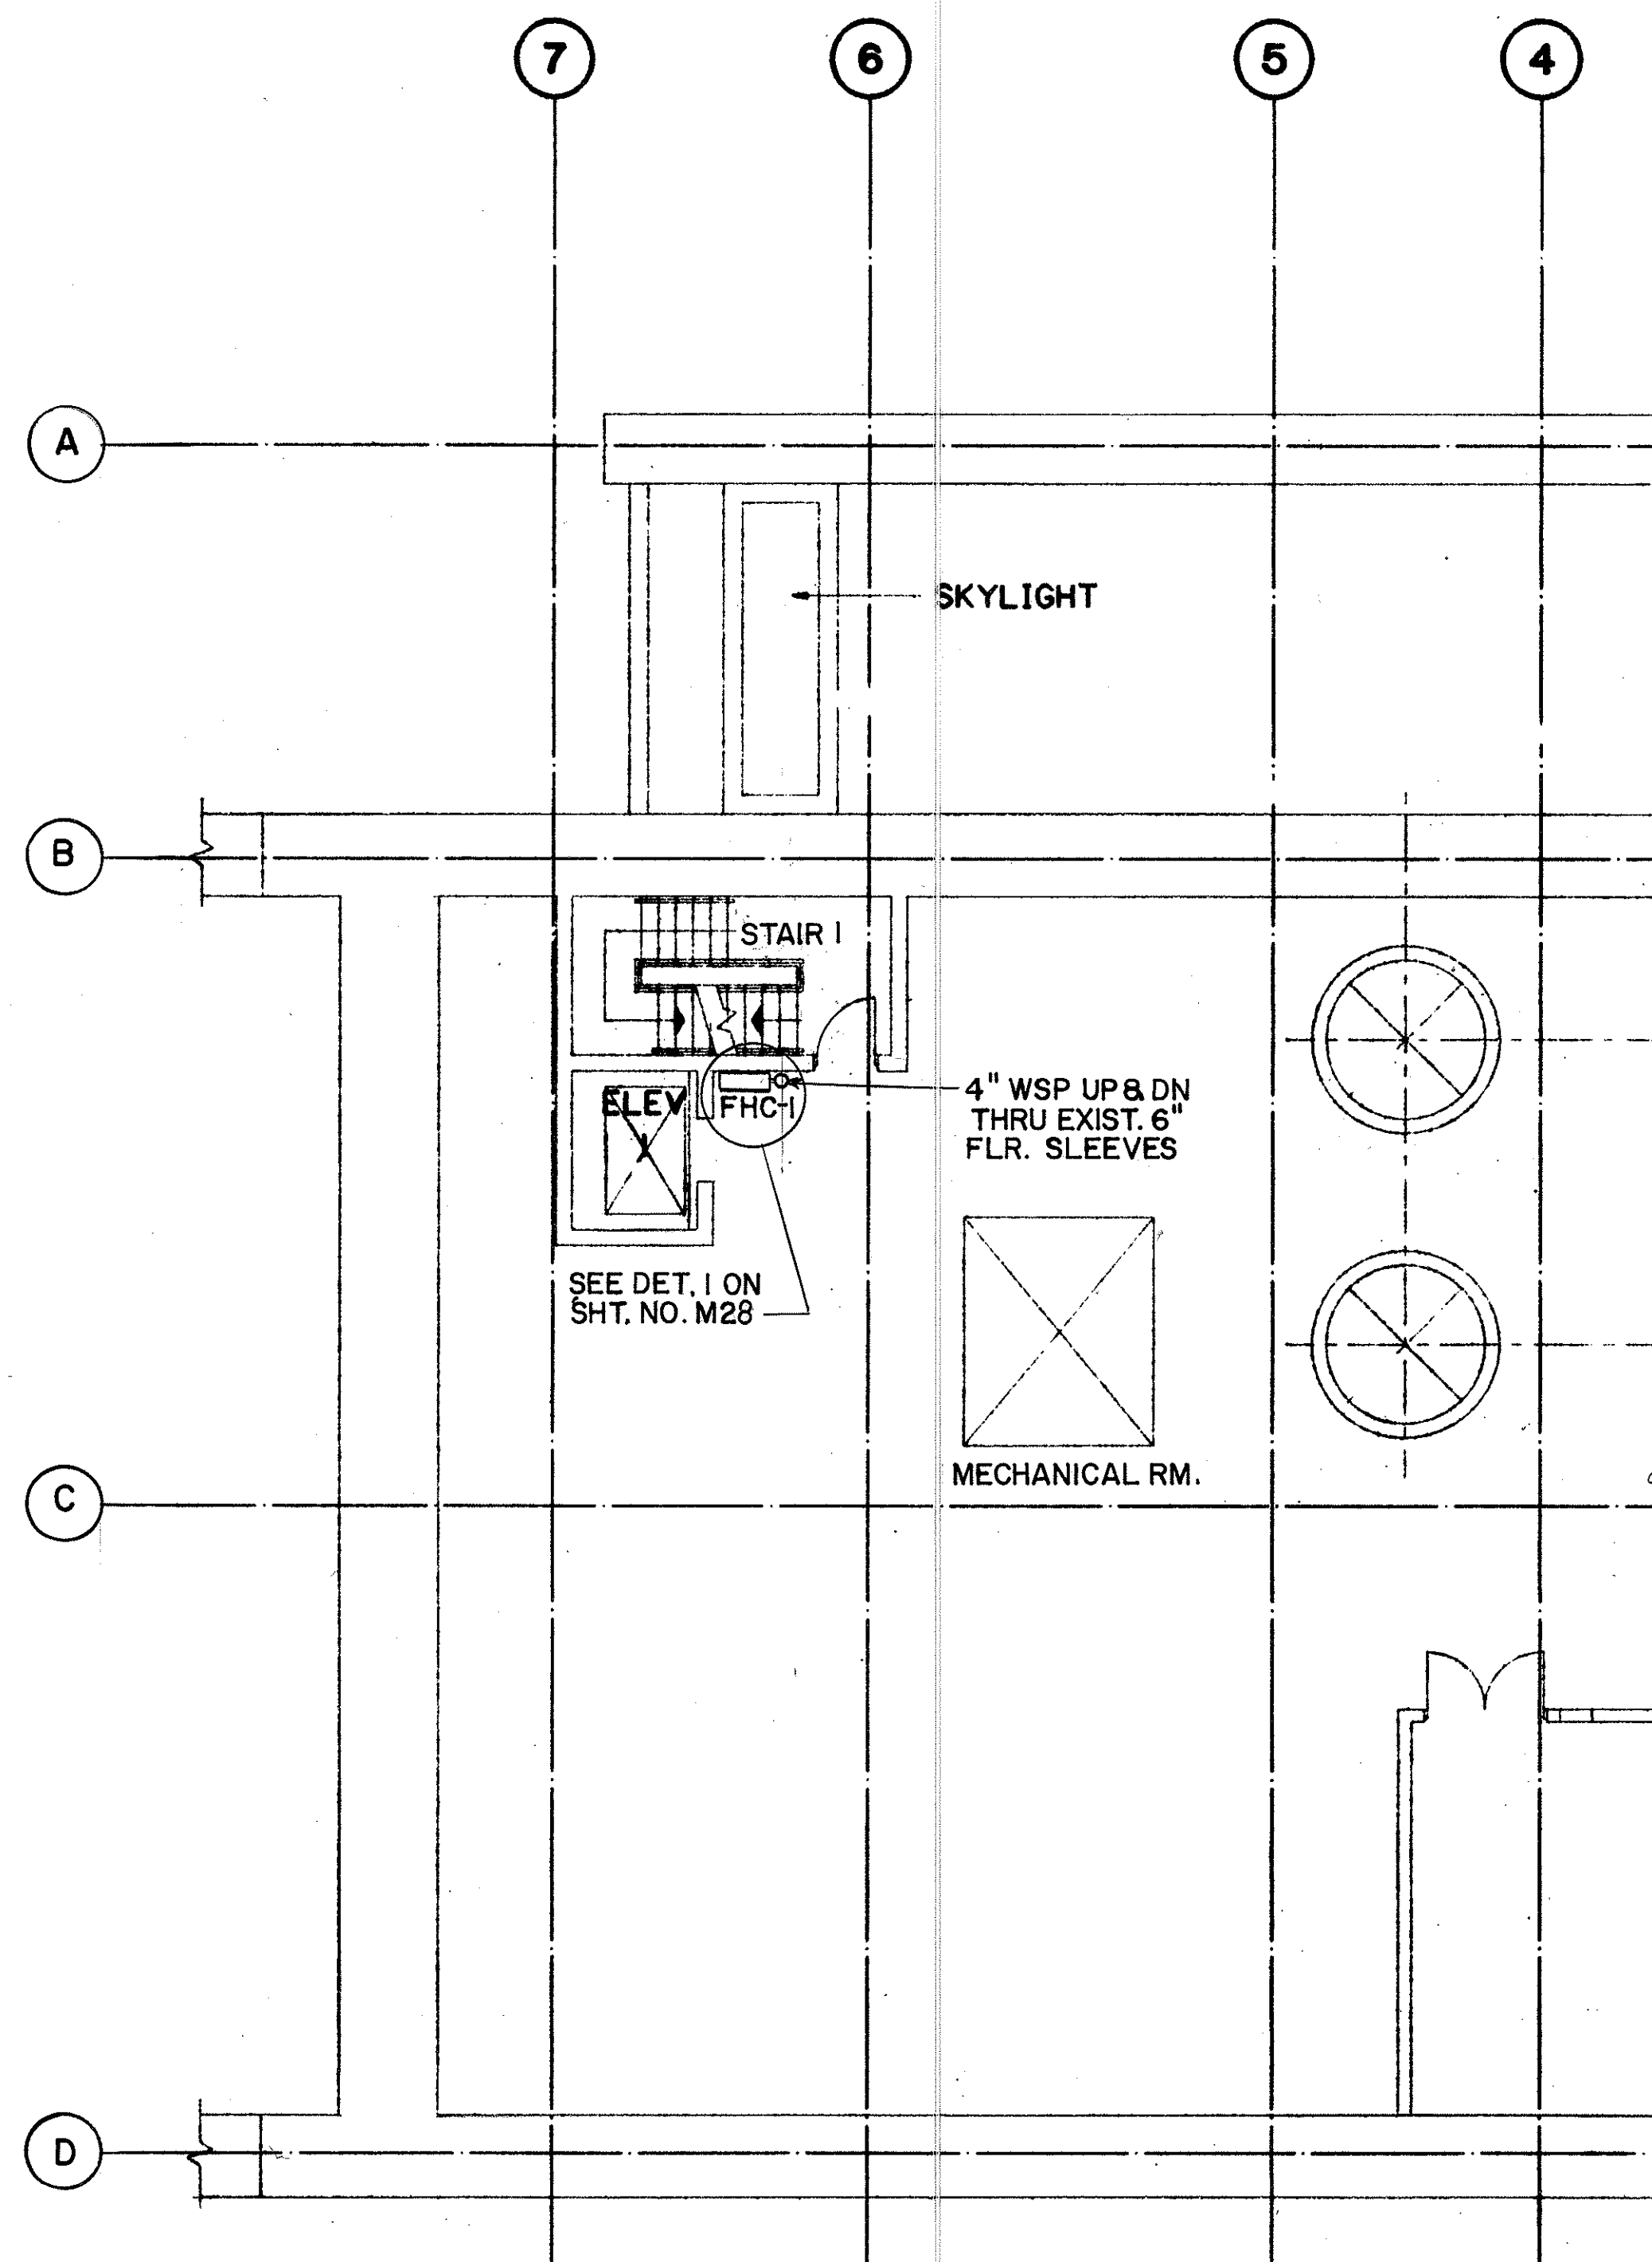

LEVEL 4 PARTIAL PLAN

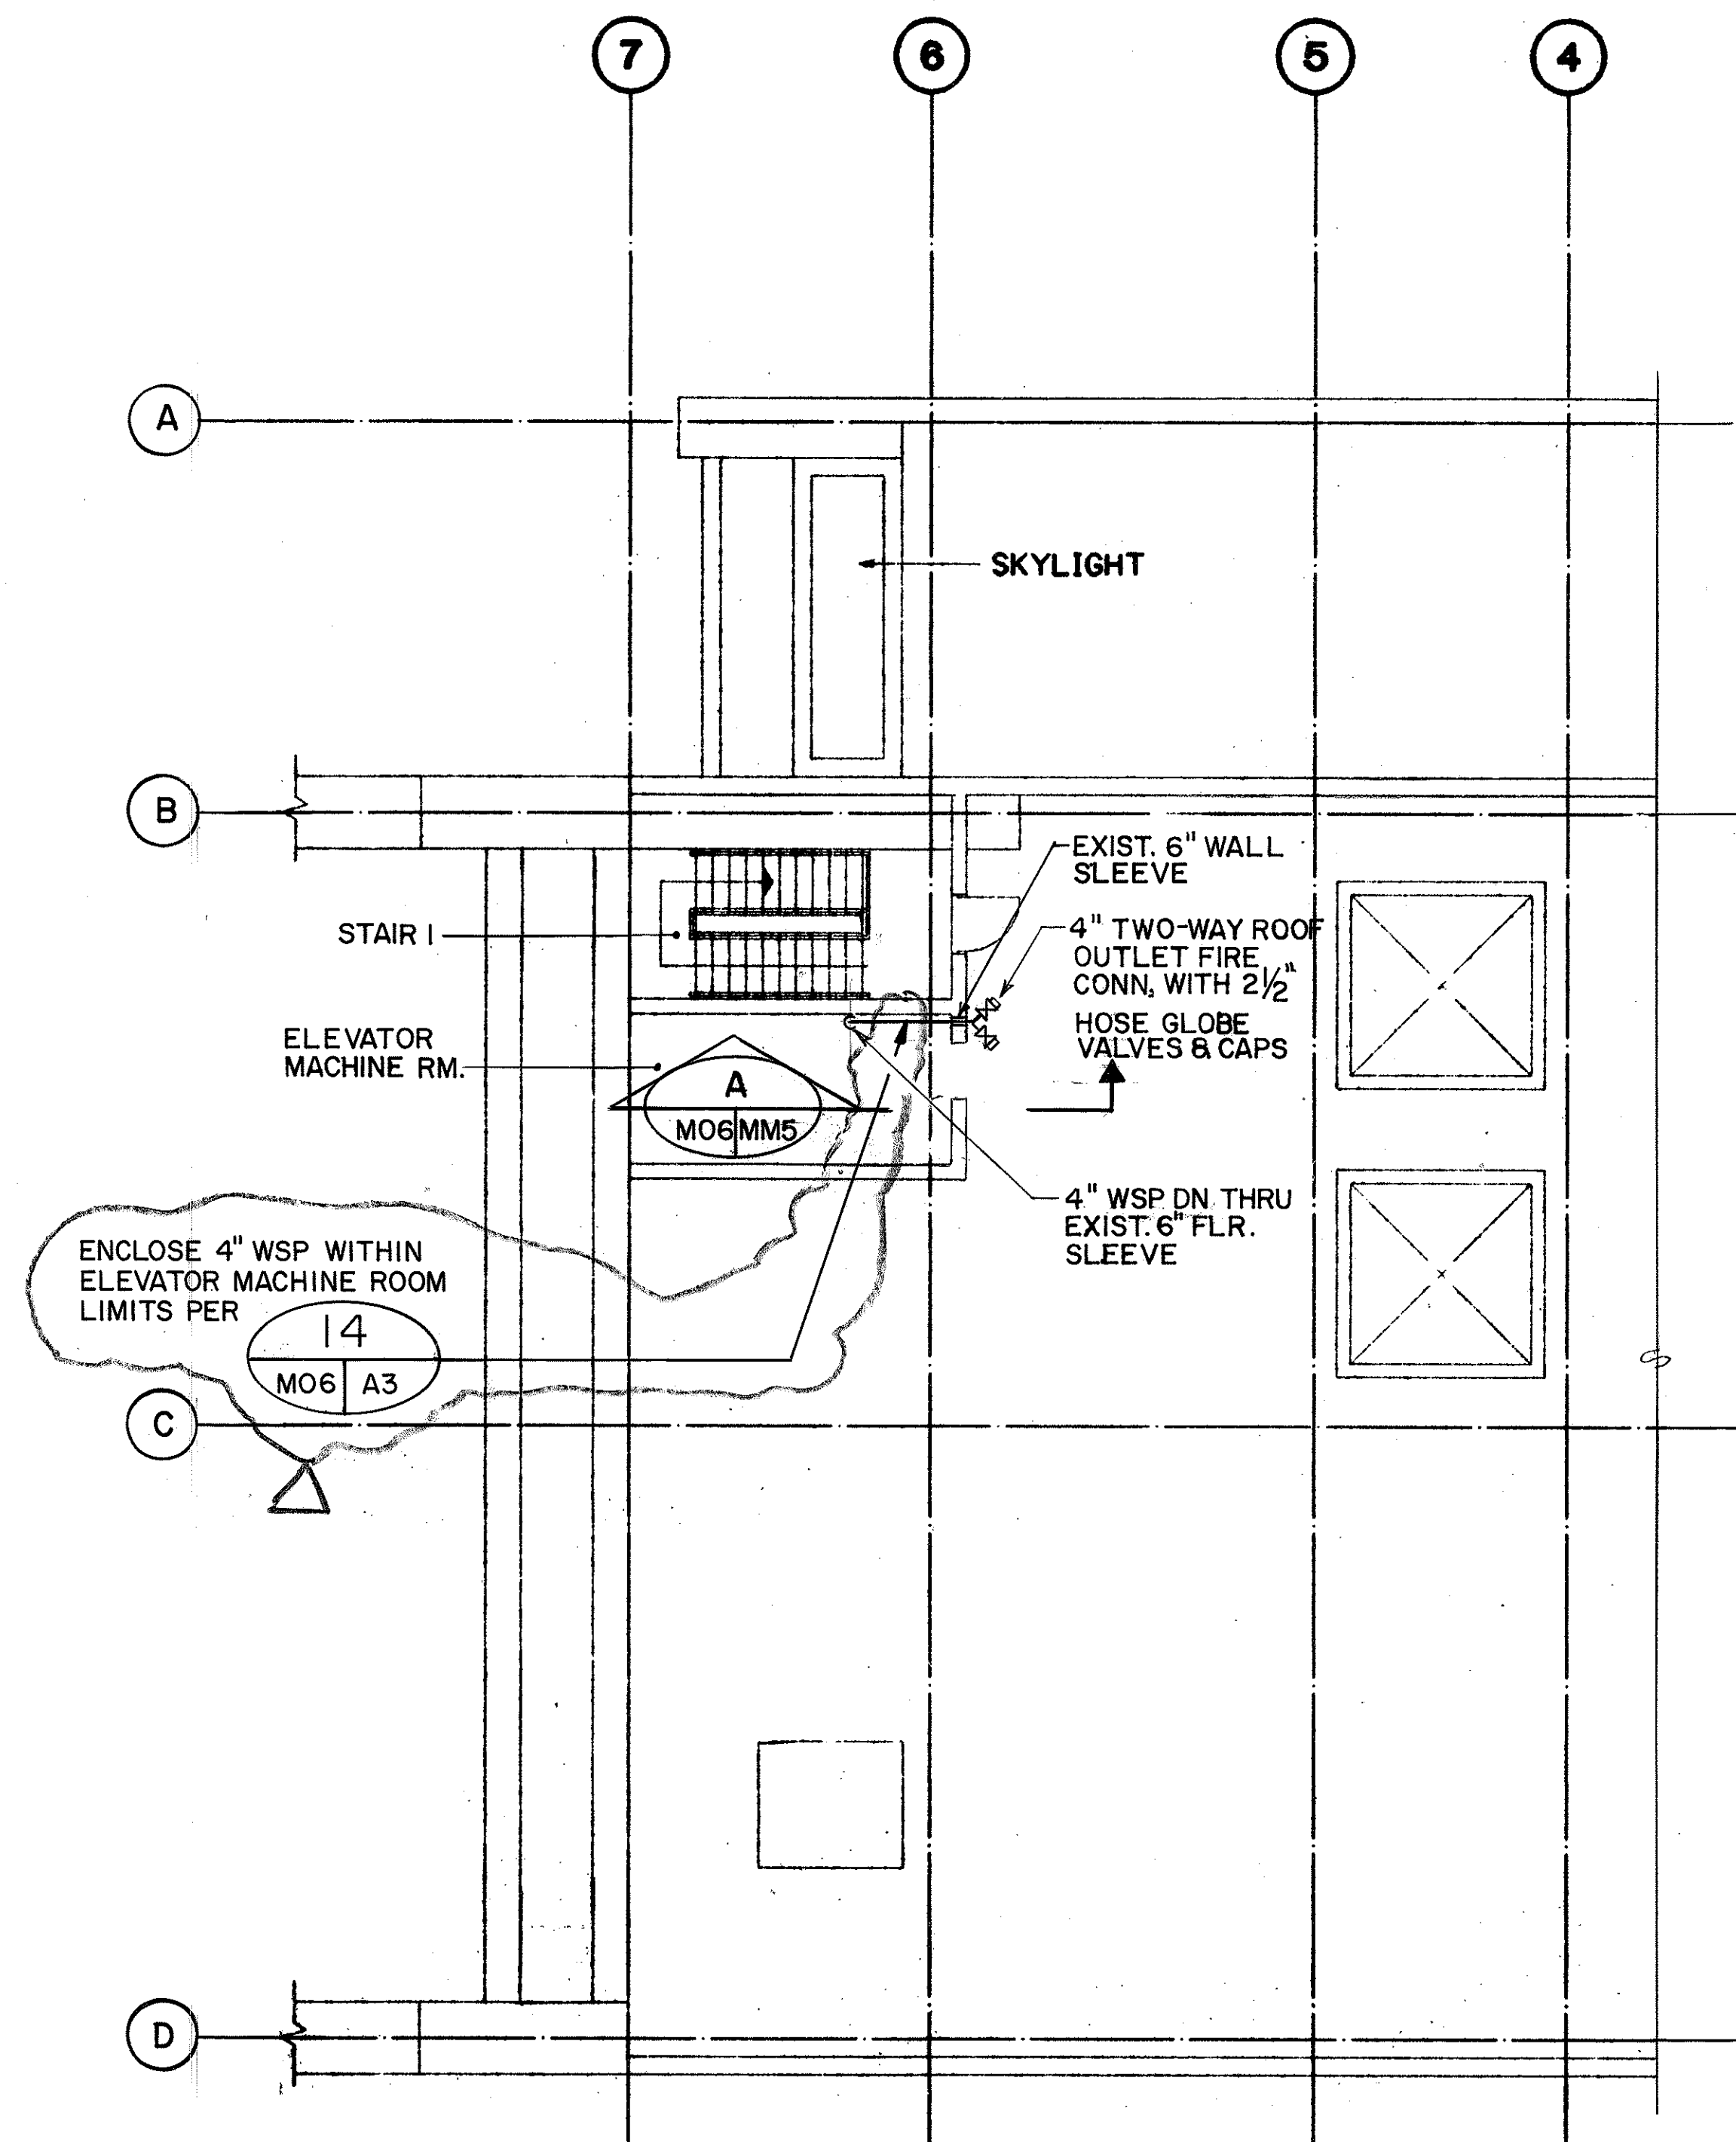

ROOF LEVEL PARTIAL PLAN

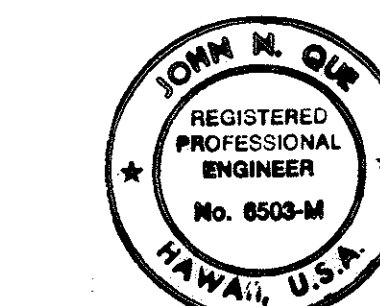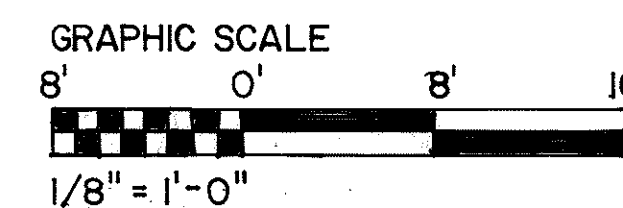


THIS WORK WAS PREPARED BY ME OR UNDER MY SUPERVISION

John M. Que

9/19/94	REV. PER DCN 66-052
DATE	REVISION
STATE OF HAWAII DEPARTMENT OF TRANSPORTATION HIGHWAYS DIVISION FIRE PROTECTION-LEVEL 4 & ROOF PARTIAL PLANS HALAWA PORTAL BUILDING - OB INTERSTATE ROUTE H-3 F.A.I. PROJ. NO. I-H3-1 (66) SCALE: 1/8"=1'-0" DATE: APR 1992 SHEET NO. M06 OF 6 SHEETS	

ORIGINAL PLAN	DATE: 12/6/89
DRAWN BY: P.L. LALOUÉ	DESIGNED BY: P.L. LALOUÉ
NOTED BY: P.L. LALOUÉ	CHECKED BY: J.N. QUE
NO.	06/04/90


FED. ROAD DIST. NO.	STATE	FED. AID PROJ. NO.	FISCAL YEAR	SHEET NO.	TOTAL SHEETS
HAWAII	HAW.	I-H3-1(66)	1992	55	440

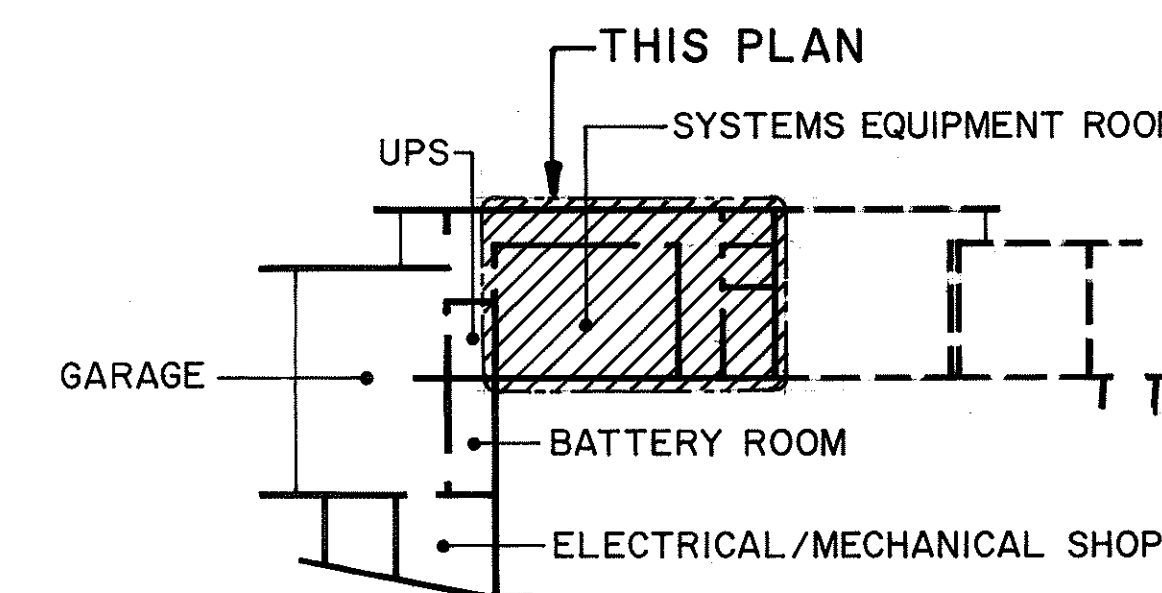

KEY PLAN

NOTES:


1. FOR LEGEND AND GENERAL NOTES REFER TO SHEET NO. M1.
2. FOR AIR CONDITIONING UNIT SCHEDULE REFER TO SHEET NO. M4.
3. FOR AIR DISTRIBUTION DEVICE SCHEDULE REFER TO SHEET NO. M6.

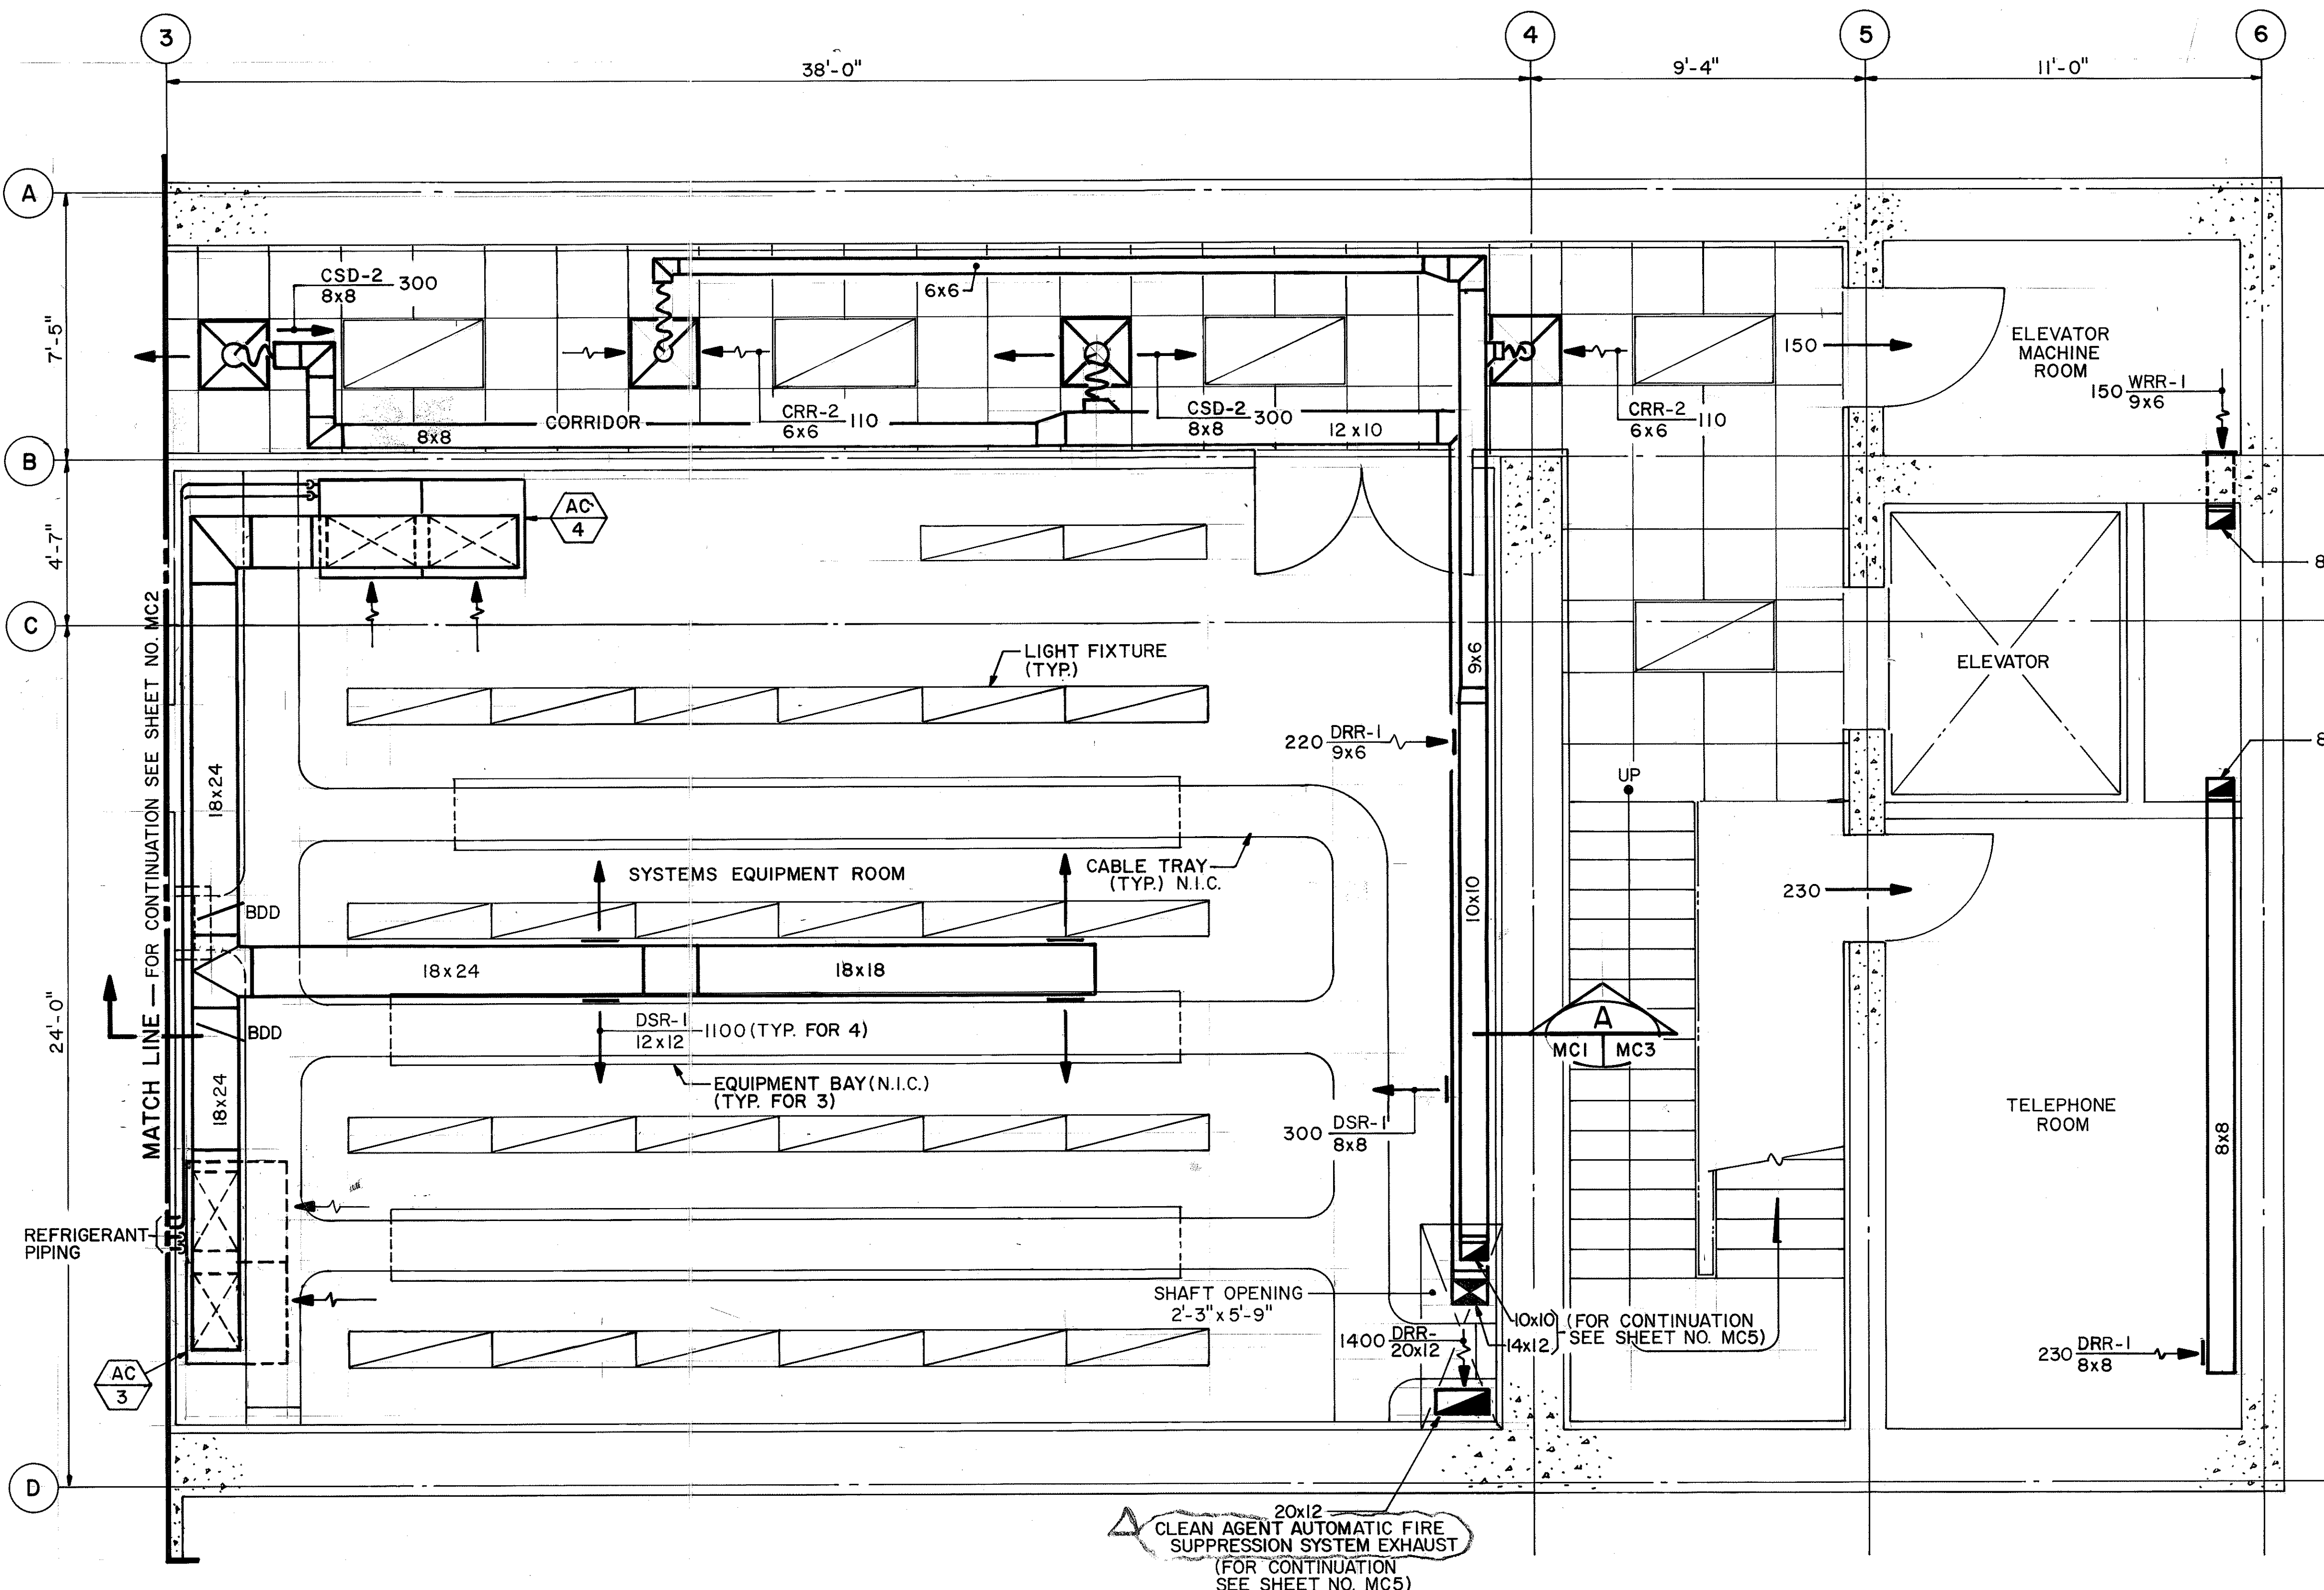


LEVEL I PARTIAL PLAN

FOR DETAIL AS-BUILT INFORMATION
REFER TO CONSTRUCTION SUBMITTALS

1/25/94	REV. PER DCN 66-034
DATE	REVISION
STATE OF HAWAII DEPARTMENT OF TRANSPORTATION HIGHWAYS DIVISION	
HVAC	
LEVEL I PARTIAL PLAN - I	
CONTROL BUILDING	
INTERSTATE ROUTE H-3	
F.A.I. PROJ. NO. I-H3-1 (66)	
SCALE: 3/8"=1'-0"	DATE: APR 1992
SHEET NO. MCI OF 19 SHEETS	

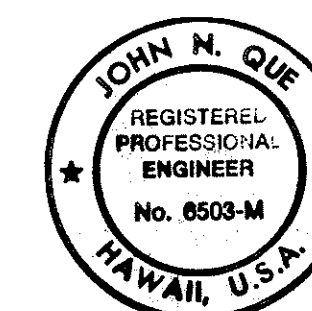


THIS WORK WAS PREPARED BY ME
OR UNDER MY SUPERVISION

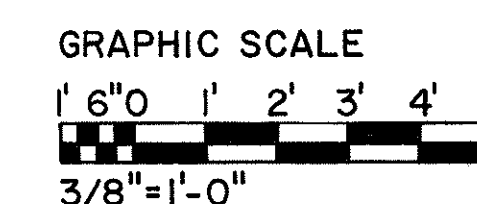


ORIGINAL PLAN	DATE
NO.	01/14/90
SURVEY PLOTTED BY	D. E. DRYDEN
DRAWN BY	D. E. DRYDEN
DESIGNED BY	D. E. DRYDEN
QUANTITIES BY	J. N. QUE
CHECKED BY	05/07/90

FED. ROAD DIST. NO.	STATE	FED. AID PROJ. NO.	FISCAL YEAR	SHEET NO.	TOTAL SHEETS
HAWAII	HAW.	1-H3-1(66)	1992	56	440

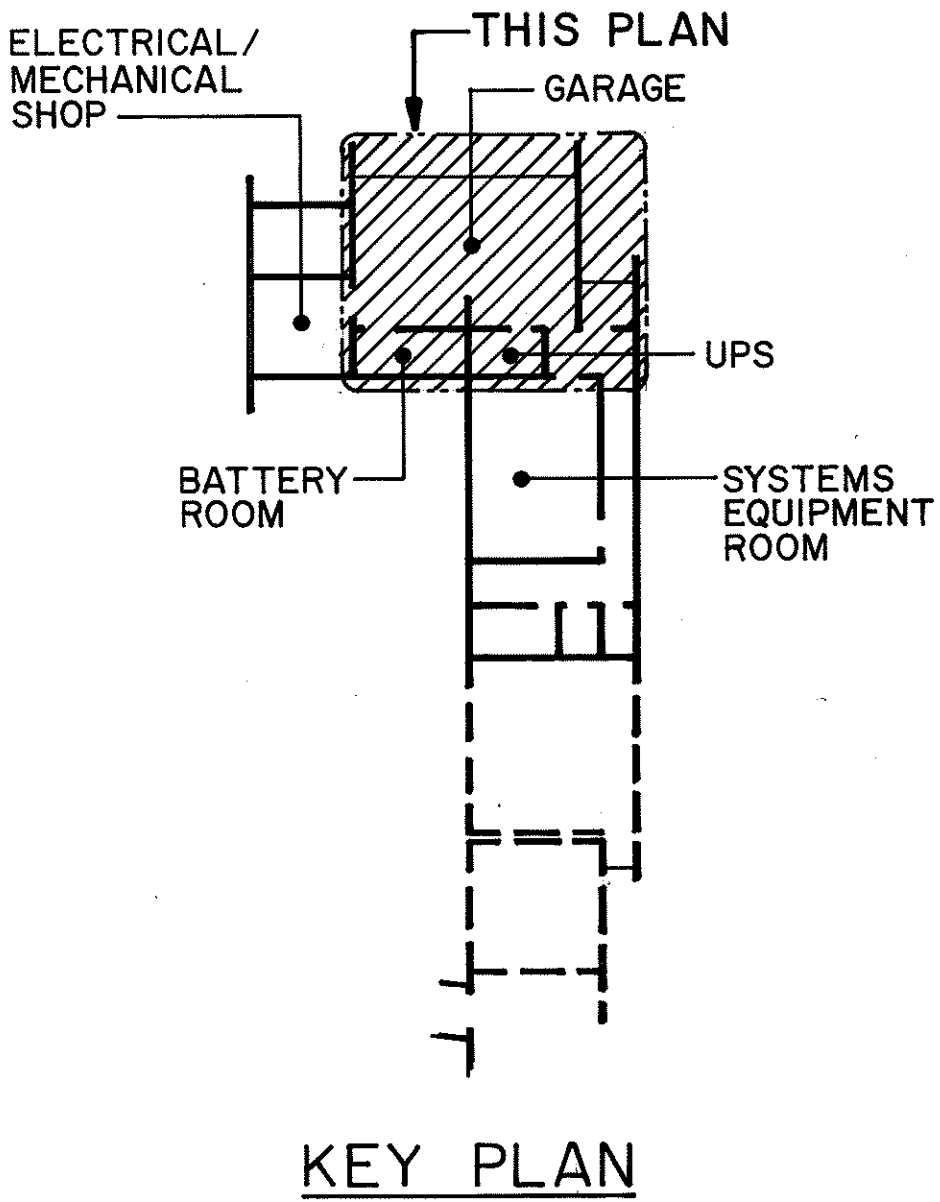

- NOTES:
- FOR LEGEND AND GENERAL NOTES REFER TO SHEET NO. M1.
 - FOR AIR DISTRIBUTION DEVICE SCHEDULE REFER TO SHEET NO. M6.
 - AFTER INSTALLATION OF REFRIGERANT PIPING SEAL OPENING BETWEEN PIPING AND SLEEVE


11/23/94	REV. PER DCN66-054
DATE	REVISION
STATE OF HAWAII DEPARTMENT OF TRANSPORTATION HIGHWAYS DIVISION HVAC LEVEL I PARTIAL PLAN-2 CONTROL BUILDING INTERSTATE ROUTE H-3 F.A.I. PROJ. NO. 1-H3-1 (66)	
SCALE: 3/8"=1'-0"	DATE: APR. 1992
SHEET NO. MC2 OF 19 SHEETS	

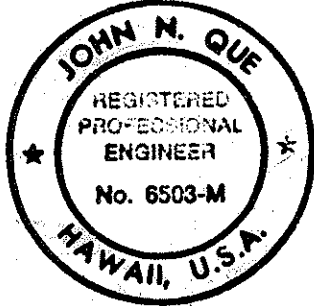


THIS WORK WAS PREPARED BY ME
OR UNDER MY SUPERVISION

John N. Que


FED. ROAD DIST. NO.	STATE	FED. AID PROJ. NO.	FISCAL YEAR	SHEET NO.	TOTAL SHEETS
HAWAII	HAW.	I-H3-1(66)	1992	56	440

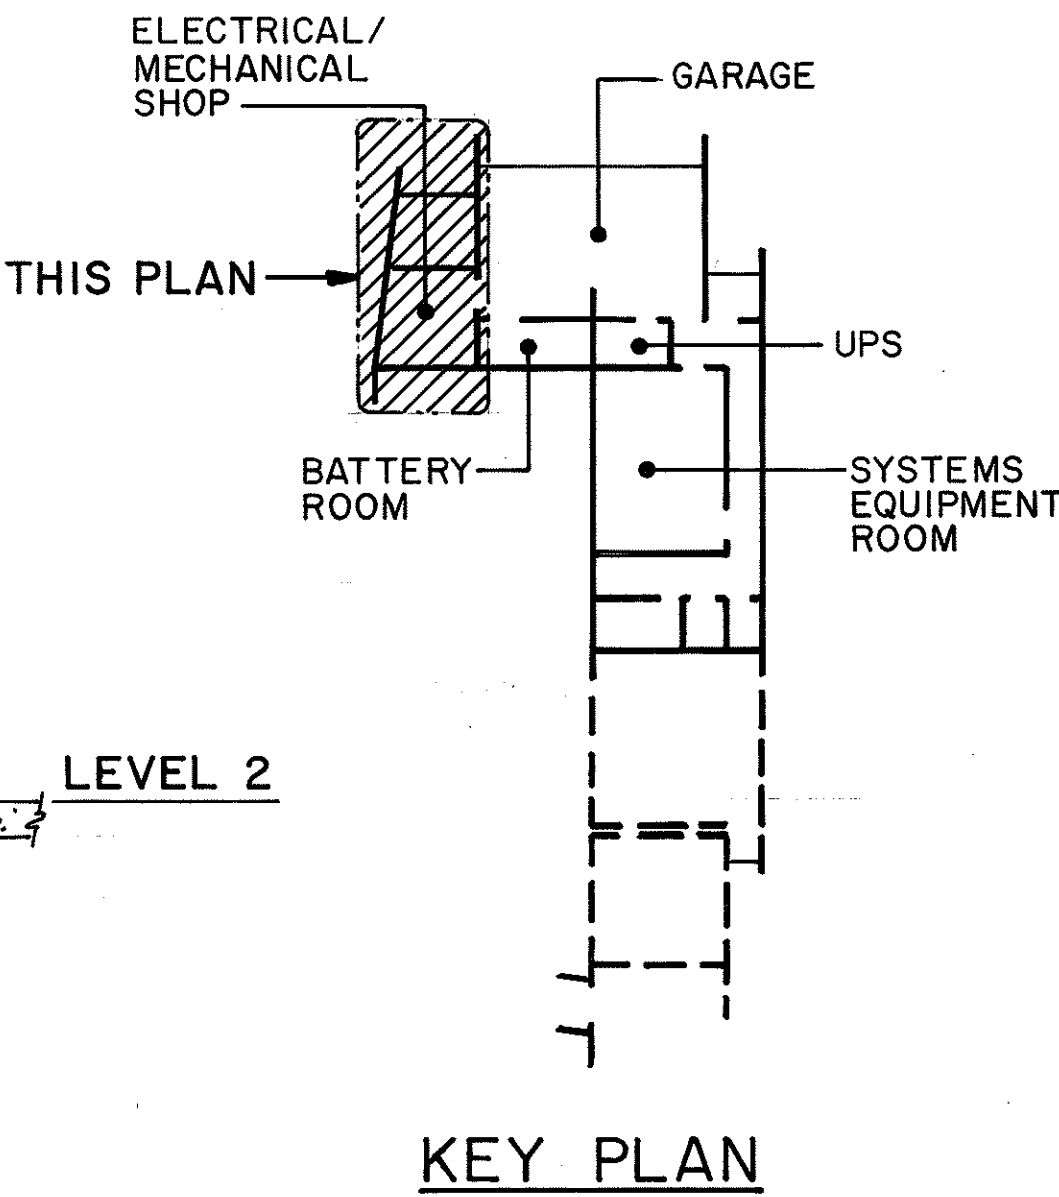



- NOTES:
- FOR LEGEND AND GENERAL NOTES REFER TO SHEET NO. M1.
 - FOR FAN SCHEDULE REFER TO SHEET NO. M5.
 - AFTER INSTALLATION OF REFRIGERANT PIPING SEAL OPENING BETWEEN PIPING AND SLEEVE.

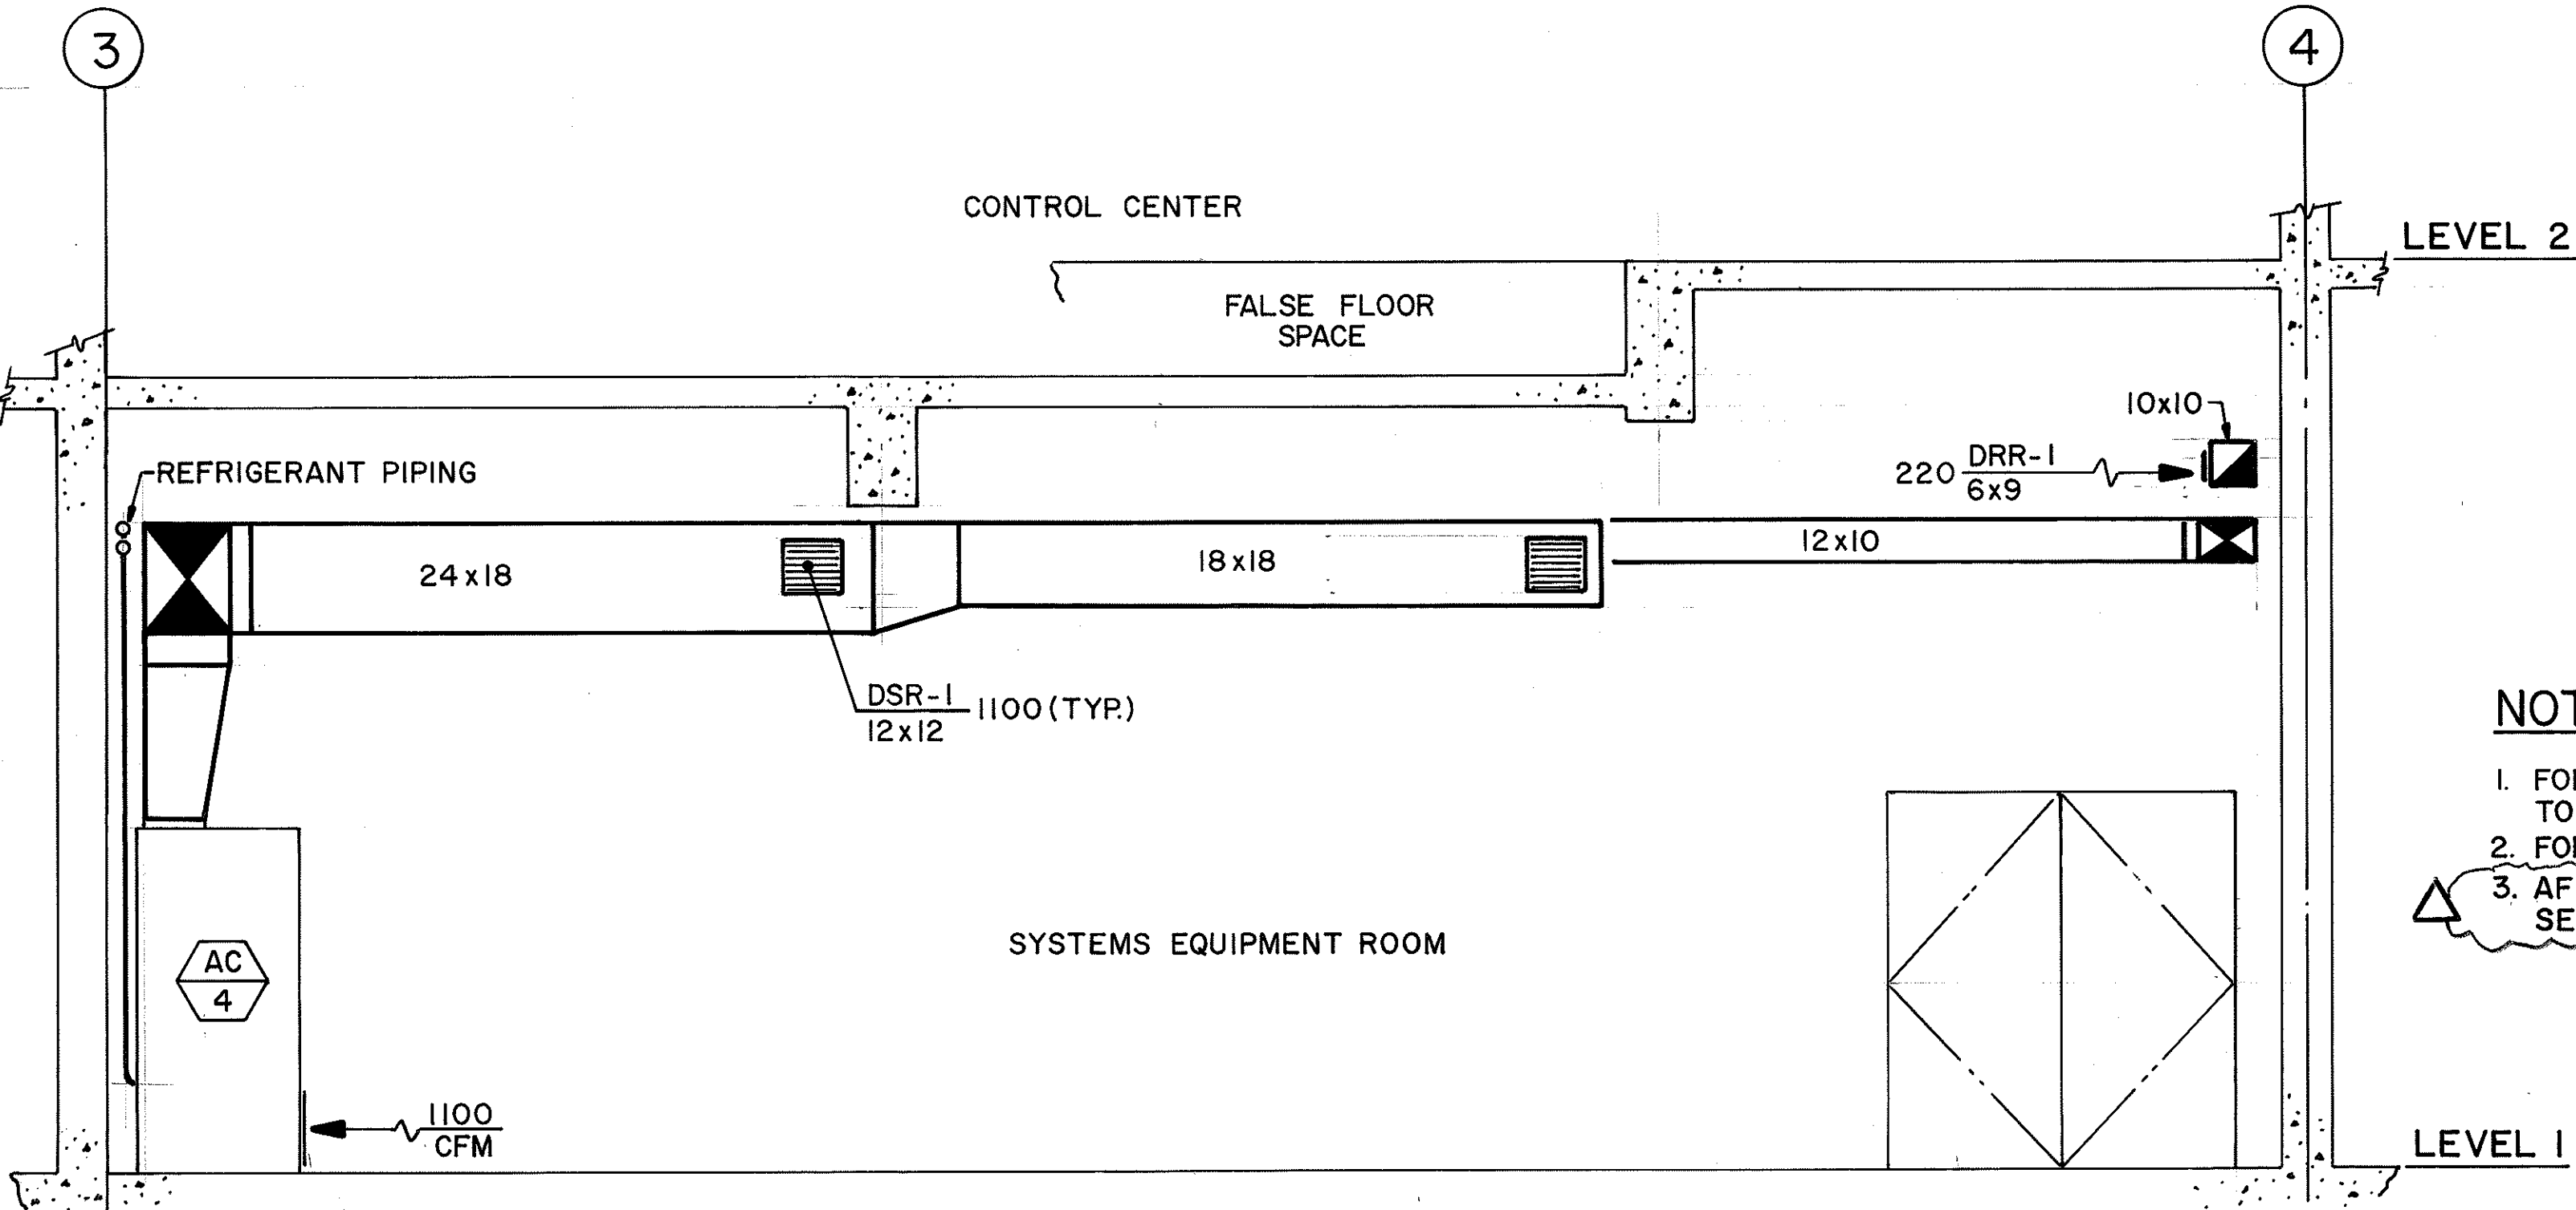

SECTION A
SCALE: 3/8"=1'-0"
MC3 MC1

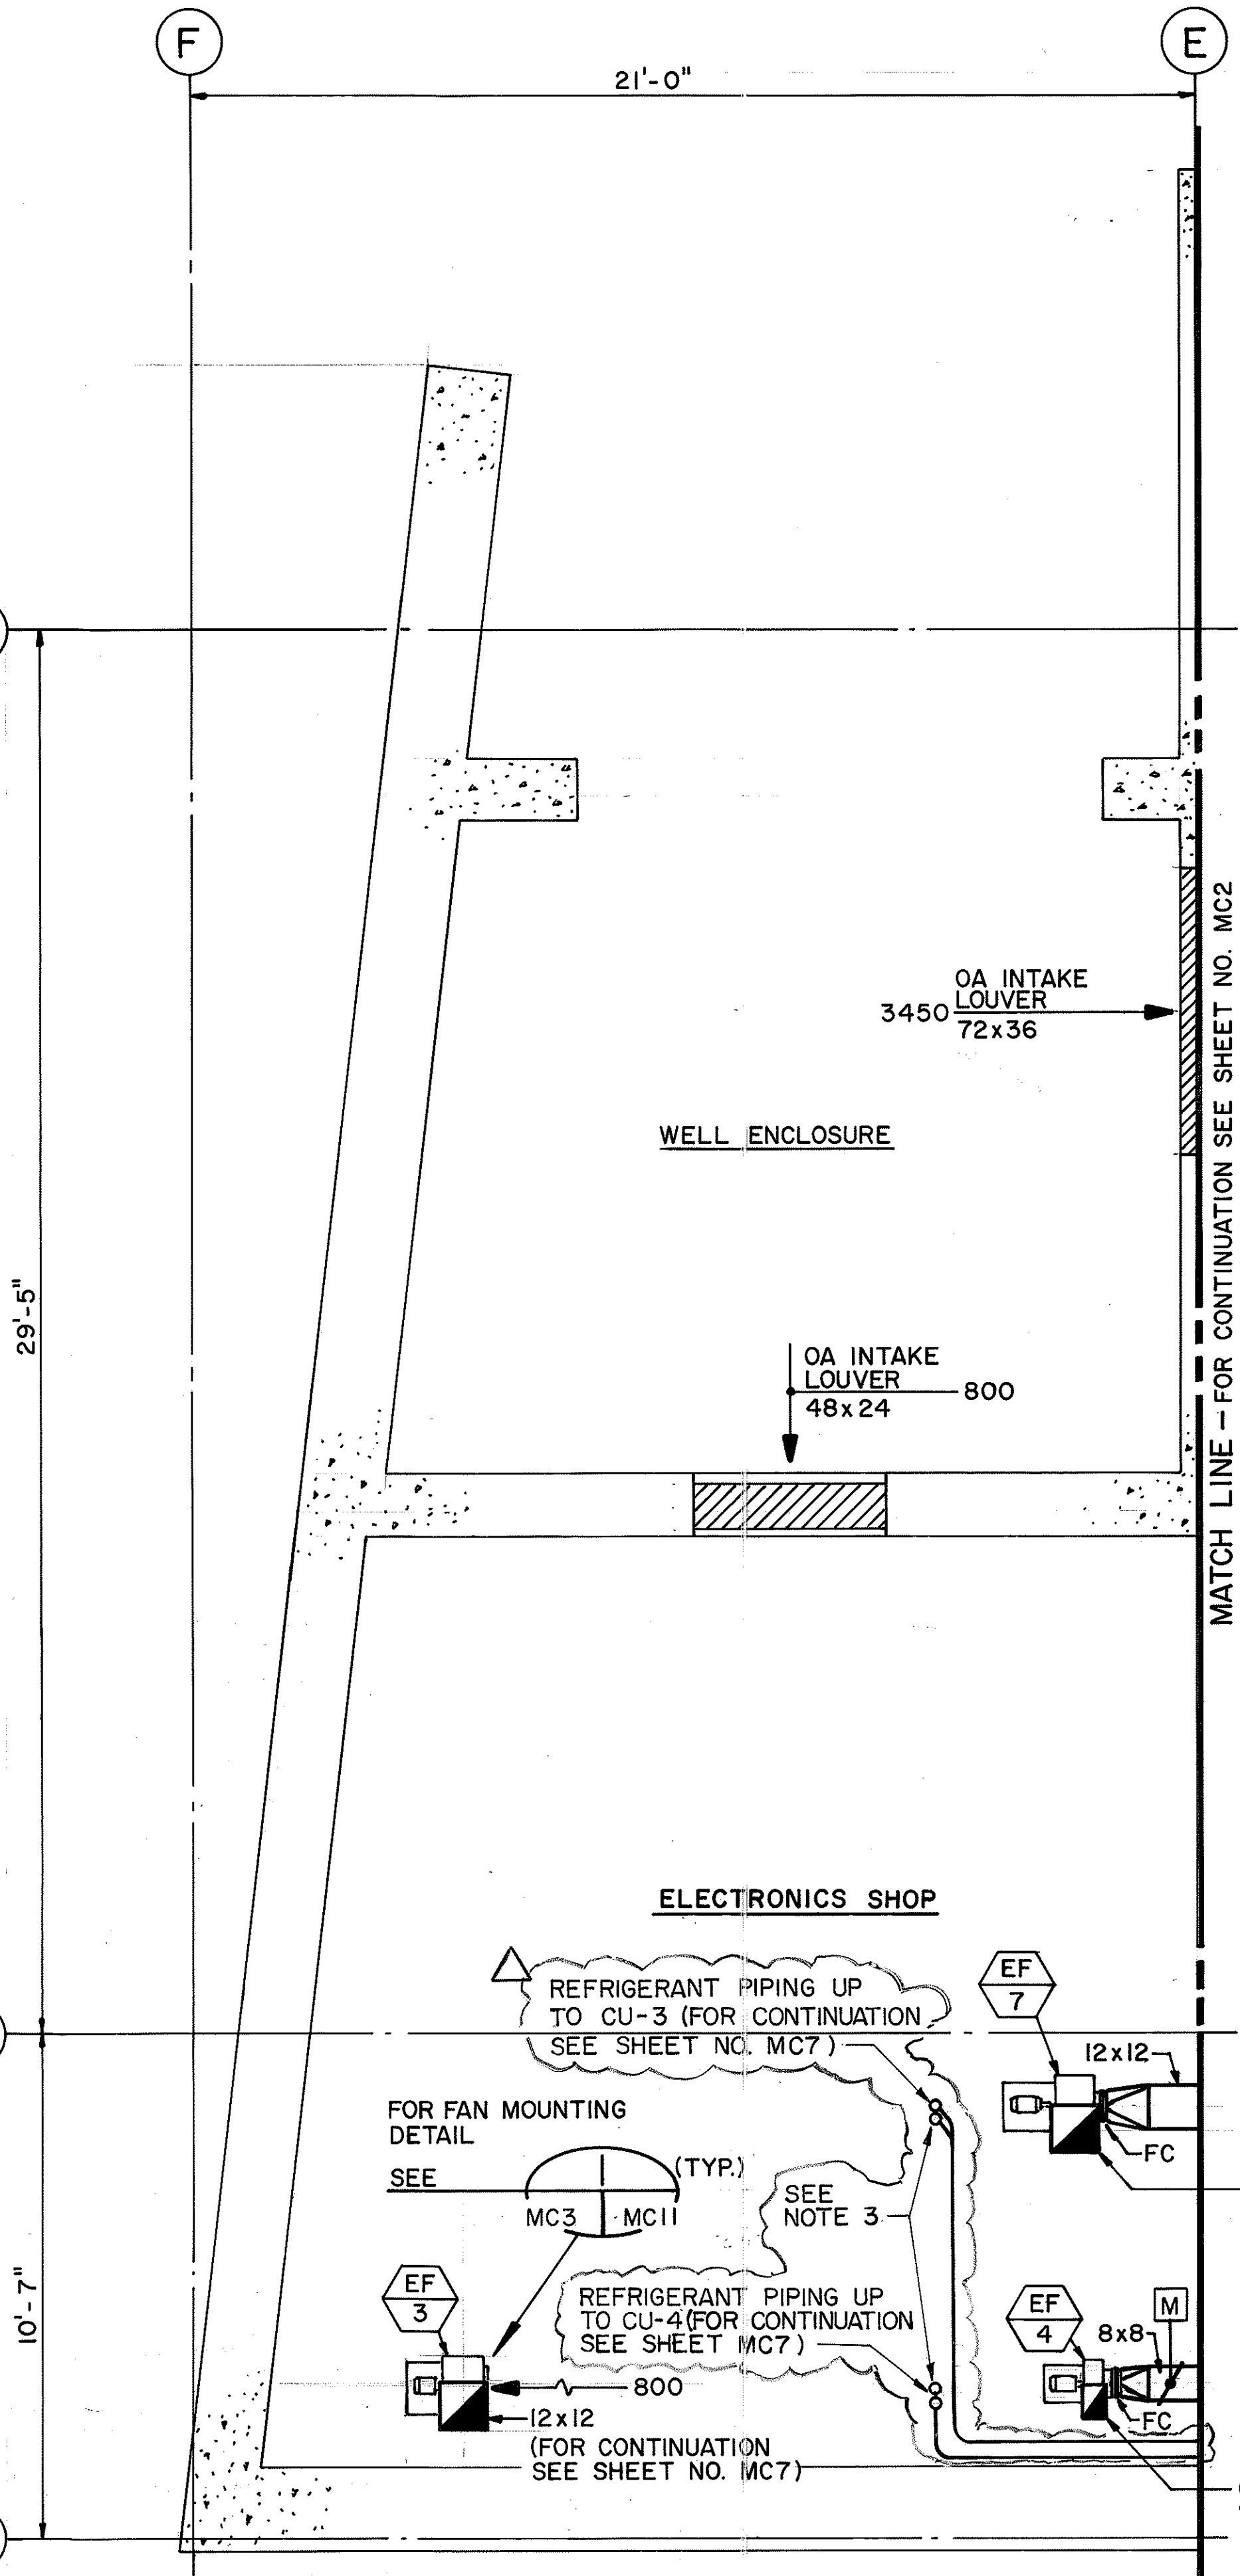

LEVEL I PARTIAL PLAN - 3
SCALE: 3/8"=1'-0"

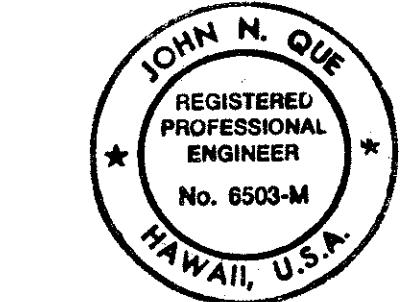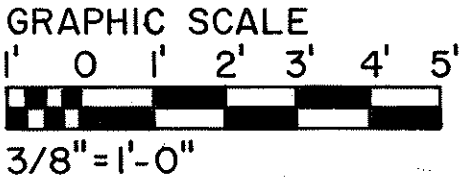


THIS WORK WAS PREPARED BY ME OR UNDER MY SUPERVISION

11/23/94	REV. PER DCN66-054
DATE	REVISION
STATE OF HAWAII DEPARTMENT OF TRANSPORTATION HIGHWAYS DIVISION HVAC - LEVEL I PARTIAL PLAN & SECTIONS CONTROL BUILDING INTERSTATE ROUTE H-3 F.A.I. PROJ. NO. I-H3-1(66) SCALE: 3/8"=1'-0" DATE: APR 1992 SHEET NO. MC3 OF 19 SHEETS	


ORIGINAL PLAN	DATE
SURVEY PLOTTED BY	01/06/90
DRAWN BY	D. E. DRYDEN
DESIGNED BY	01/04/90
NOTED BY	D. E. DRYDEN
CHECKED BY	J. N. QUE
DATE	06/07/90

FED. ROAD DIST. NO.	STATE	FED. AID PROJ. NO.	FISCAL YEAR	SHEET NO.	TOTAL SHEETS
HAWAII	HAW.	I-H3-1(66)	1992	58	440


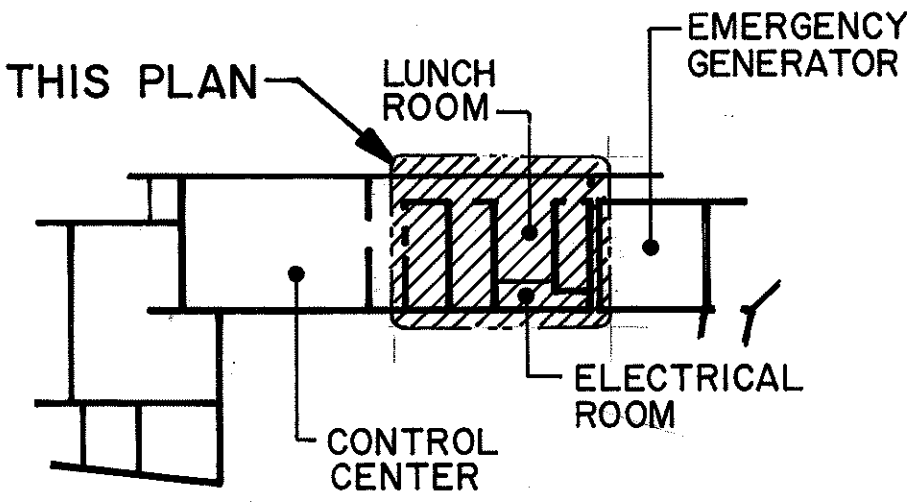


KEY PLAN

- NOTES:
- FOR LEGEND AND GENERAL NOTES REFER TO SHEET NO. M1
 - FOR AIR DISTRIBUTION DEVICE SCHEDULE REFER TO SHEET NO. M6

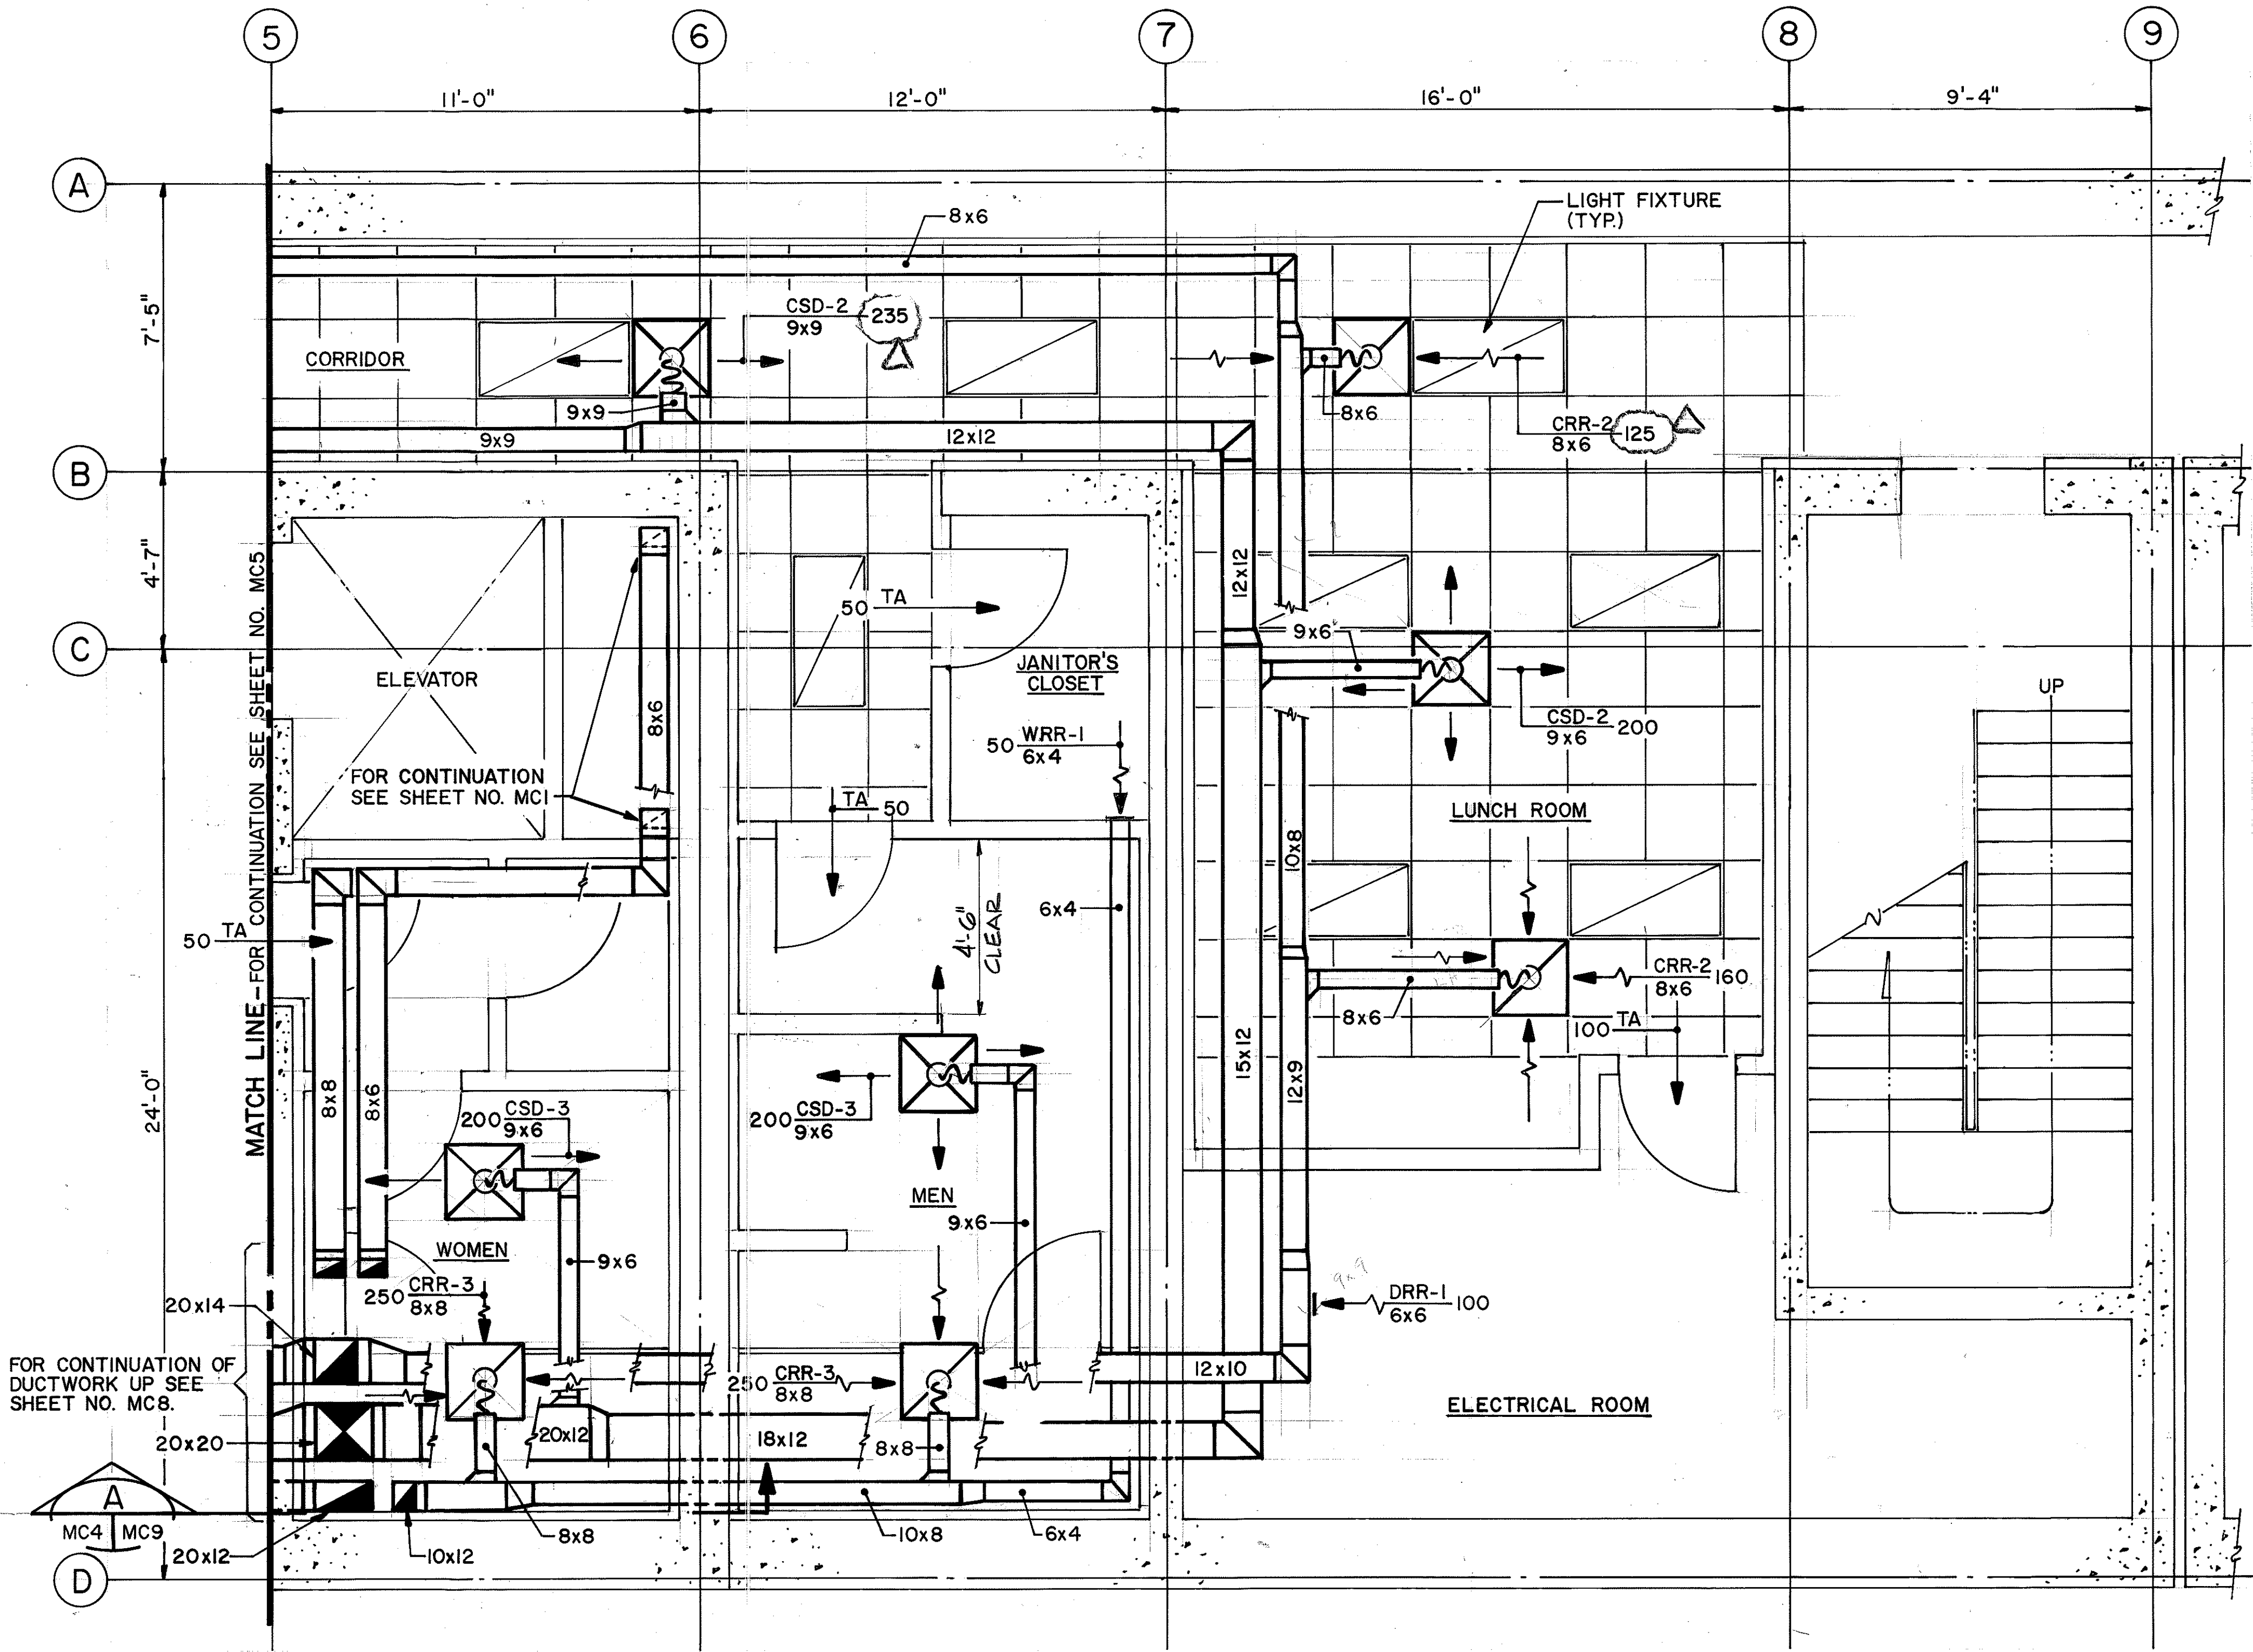

ORIGINAL PLAN	DATE
NO.	04/16/90
DESIGNED BY	D. E. DRYDEN
CHECKED BY	J. N. QUE
DATE	04/12/90
DATE	05/01/90

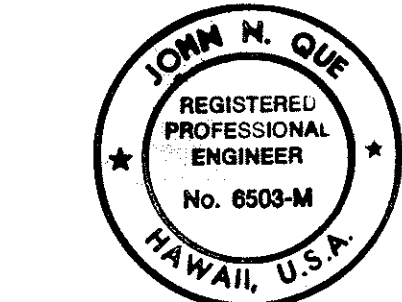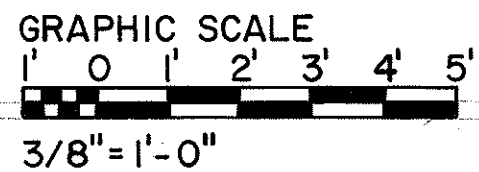


THIS WORK WAS PREPARED BY ME OR UNDER MY SUPERVISION

DATE	REVISION
11/23/94	REV. PER DCN 66-054
1/18/94	REV. CORRIDOR SUPPLY AND RETURN CFM PER DCN 66-030
2/8/93	REVISED WALL LOCATION BETWEEN MEN'S TOILET AND J.C. IN ACCORDANCE WITH ADA REGULATIONS PER DCN 66-001
STATE OF HAWAII DEPARTMENT OF TRANSPORTATION HIGHWAYS DIVISION HVAC LEVEL 2 PARTIAL PLAN-1 CONTROL BUILDING INTERSTATE ROUTE H-3 F.A.I. PROJ. NO. I-H3-1 (66) SCALE: 3/8"=1'-0" DATE: APR 1992 SHEET NO. MC4 OF 19 SHEETS	

A schematic key plan of the building layout. The plan shows a central corridor connecting several rooms. On the left is the GARAGE ROOF. Moving right, there is a CONTROL CENTER (shaded with diagonal lines), followed by a LUNCH ROOM, an EMERGENCY GENERATOR, and an ELECTRICAL ROOM. A line points from the text 'THIS PLAN' to the top of the CONTROL CENTER. The title 'KEY PLAN' is centered below the diagram.

1. FOR LEGEND AND GENERAL NOTES REFER TO SHEET NO. M1
2. FOR AIR DISTRIBUTION DEVICE SCHEDULE REFER TO SHEET NO. M6

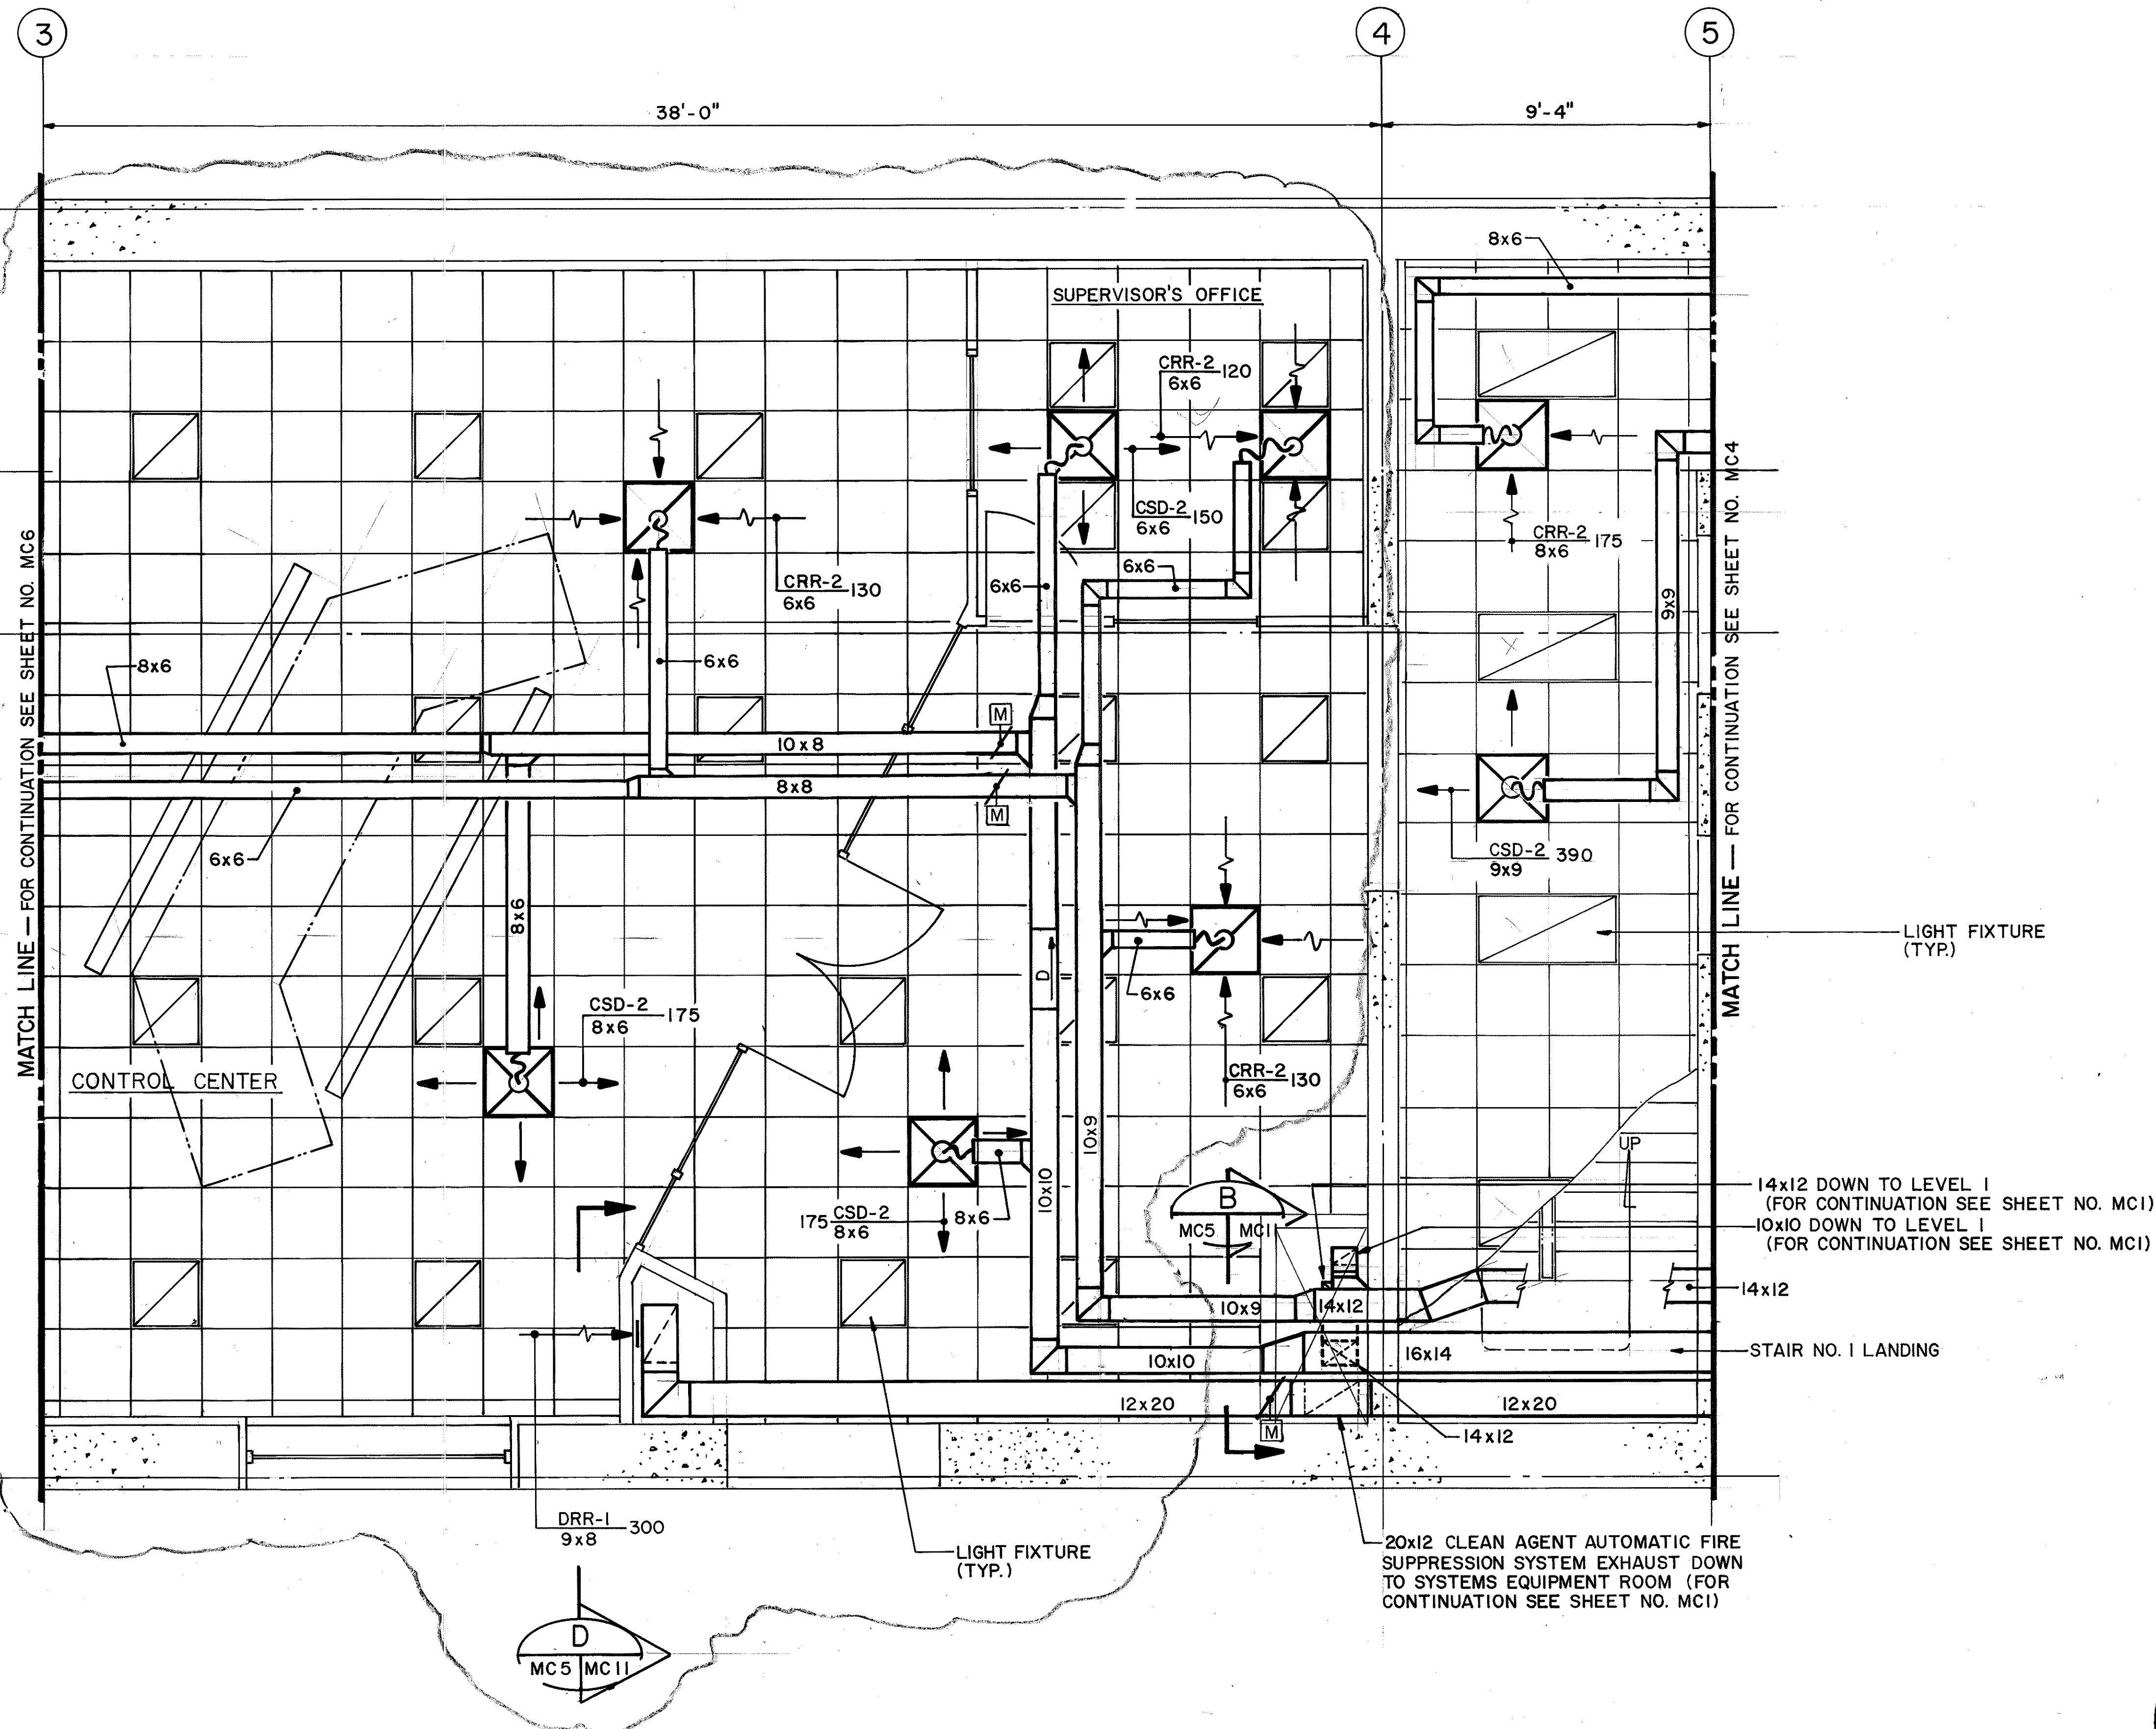

12/16/94	REV. PER DCN 66-054
1/25/94	REV. PER DCN 66-034
1/6/94	REVISED CONTROL CENTER LAYOUT PER DCN 66-030
DATE	REVISION

STATE OF HAWAII
 DEPARTMENT OF TRANSPORTATION
 HIGHWAYS DIVISION

HVAC

LEVEL 2 PARTIAL PLAN-2

CONTROL BUILDING


INTERSTATE ROUTE H-3
F.A.I. PROJ. NO. I-H3-1 (66)

SCALE: 3/8"=1'-0"
DATE: APR 1992

SHEET NO. MC5 OF 19 SHEETS






NOTES:

1. FOR LEGEND AND GENERAL NOTES REFER TO SHEET NO. M1.
2. FOR FAN SCHEDULE REFER TO SHEET NO. M5.

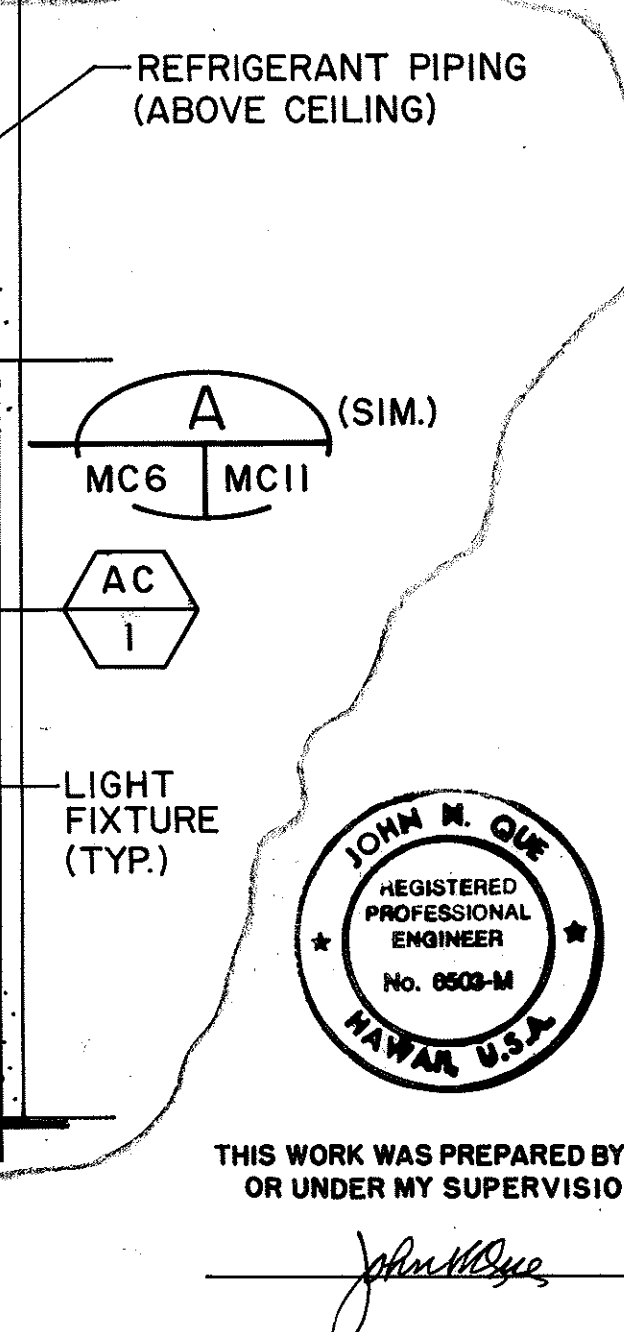

ORIGINAL PLAN	SURVEY PLOTTED BY	DATE
	D. E. DRYDEN	01/10/90
NOTE BOOK	DRAWN BY	"
	D. E. DRYDEN	01/06/90
	DESIGNED BY	"
	QUANTITIES BY	"
No.	CHECKED BY	06/01/90
	J. N. QUE	



FED. ROAD DIST. NO.	STATE	FED. AID PROJ. NO.	FISCAL YEAR	SHEET NO.	TOTAL SHEETS
HAWAII	HAW.	I-H3-1(66)	1992	61	440

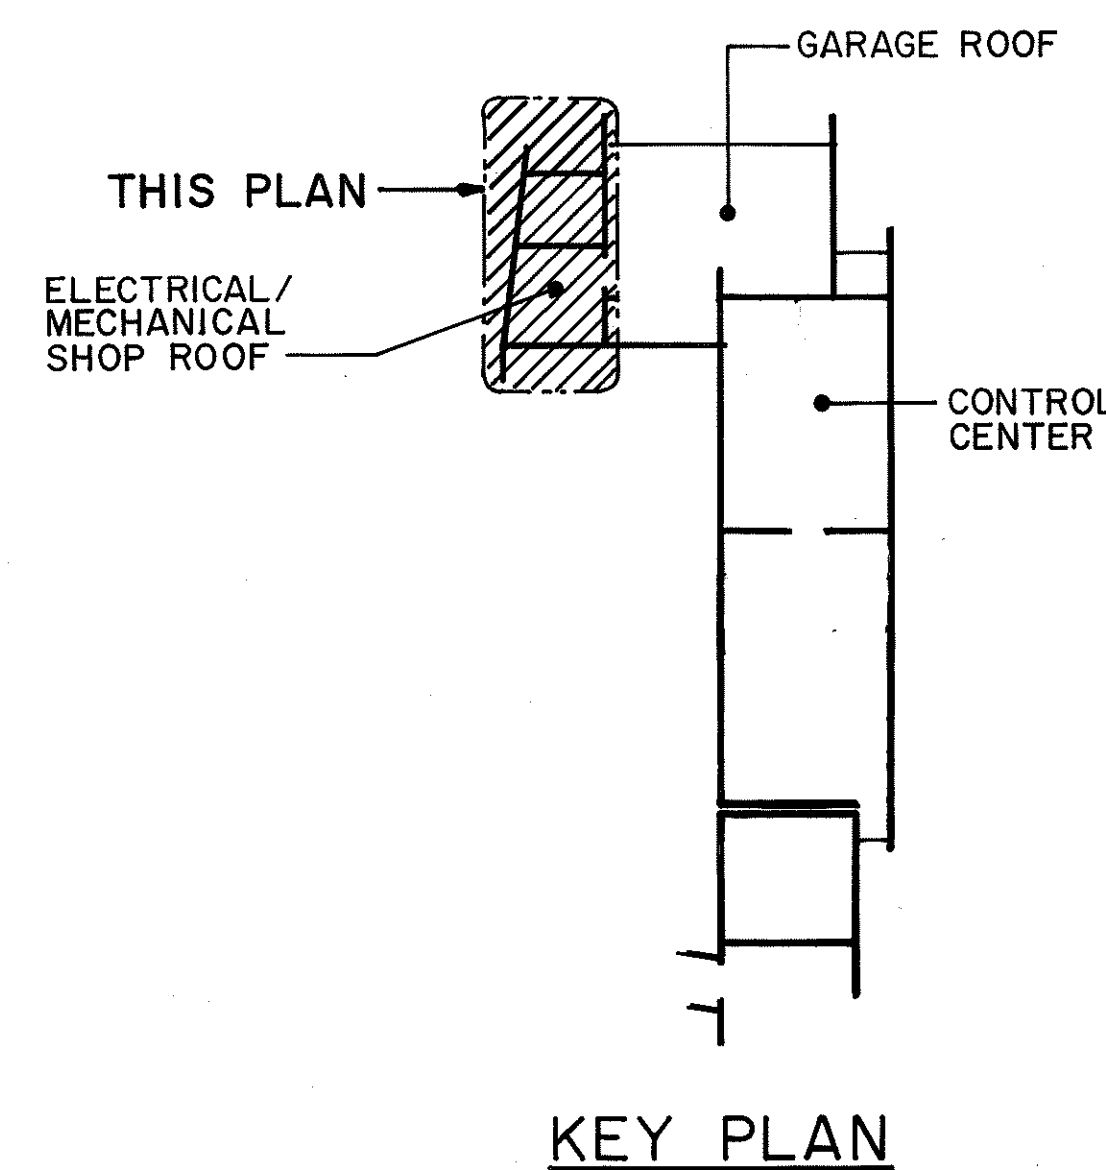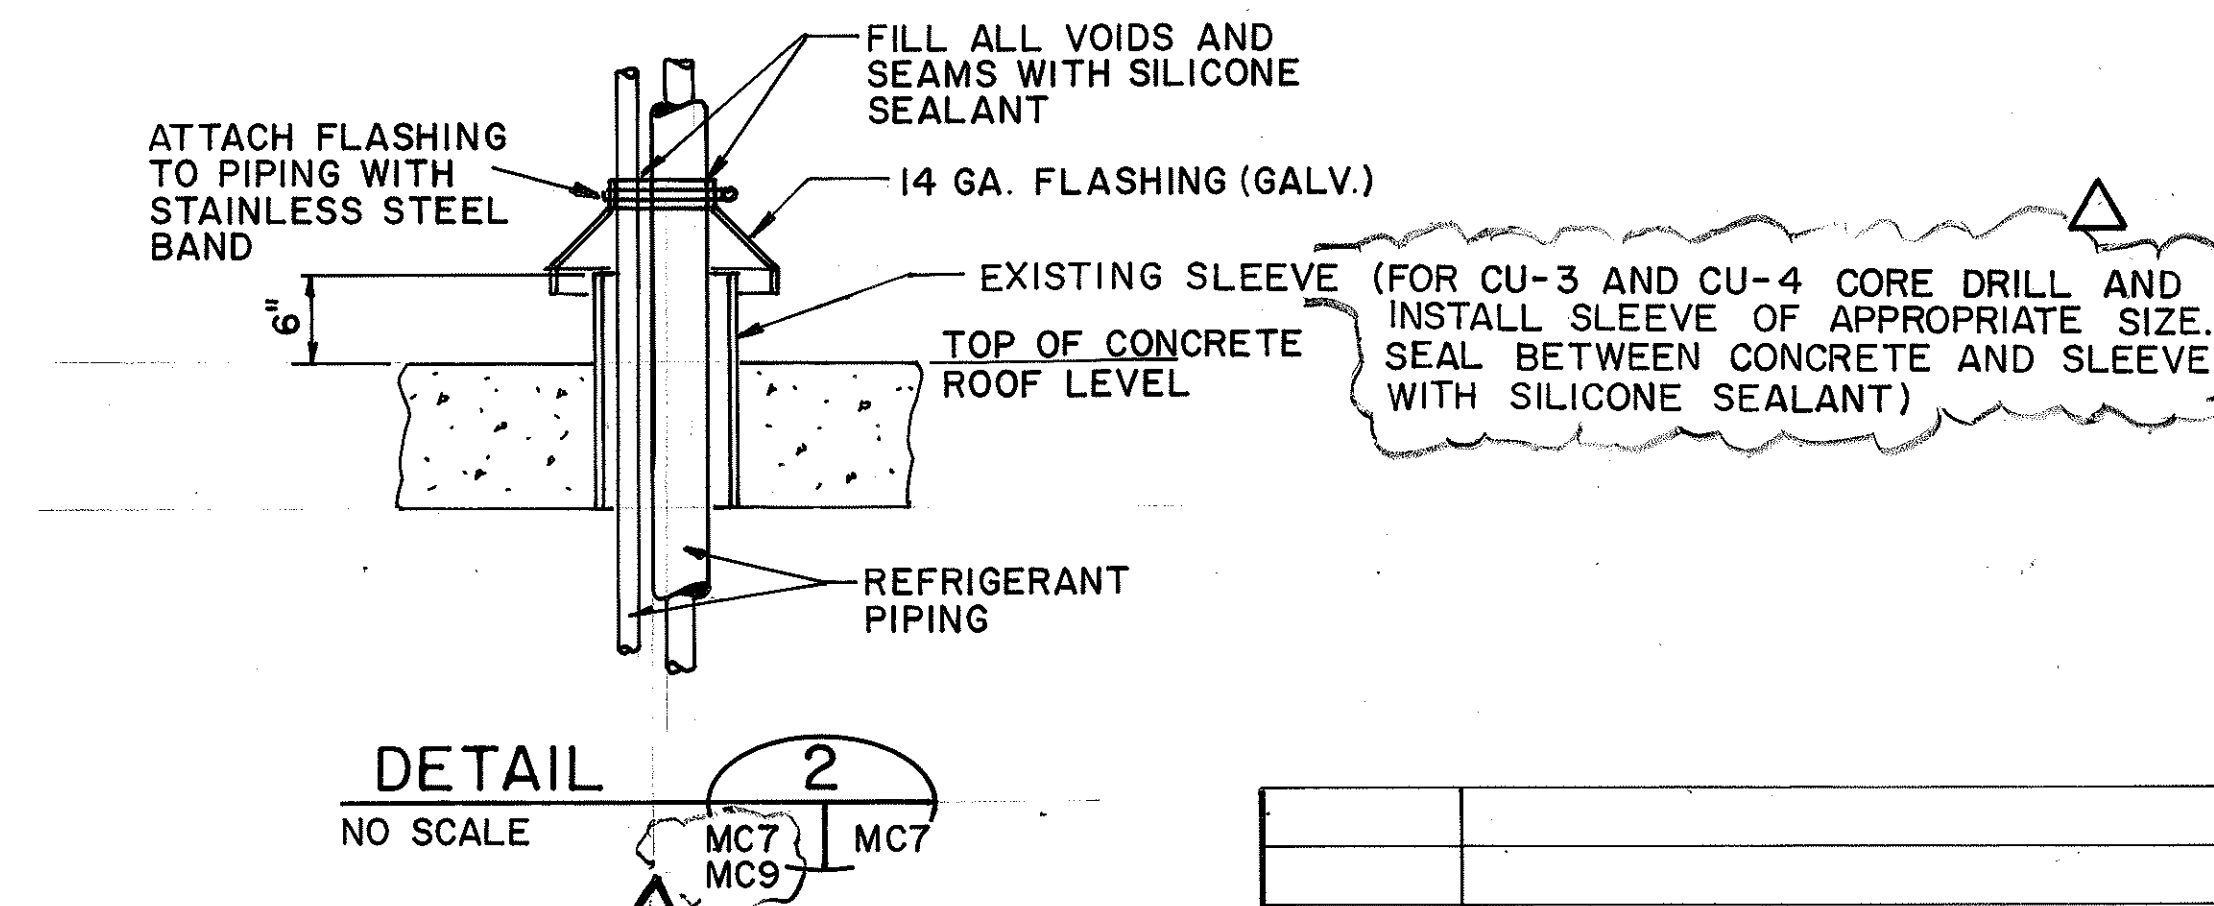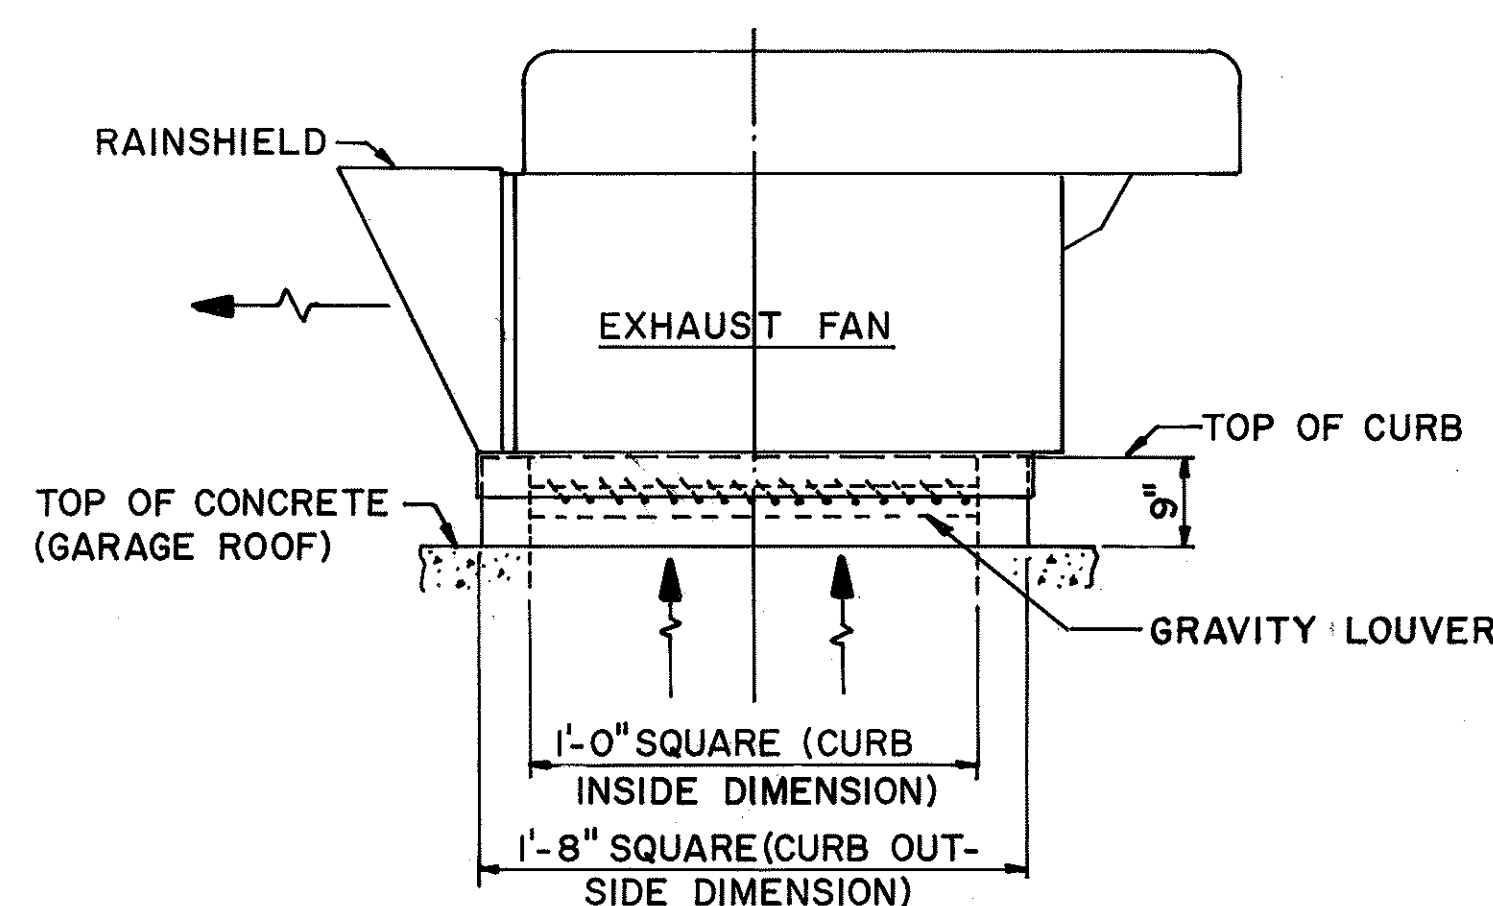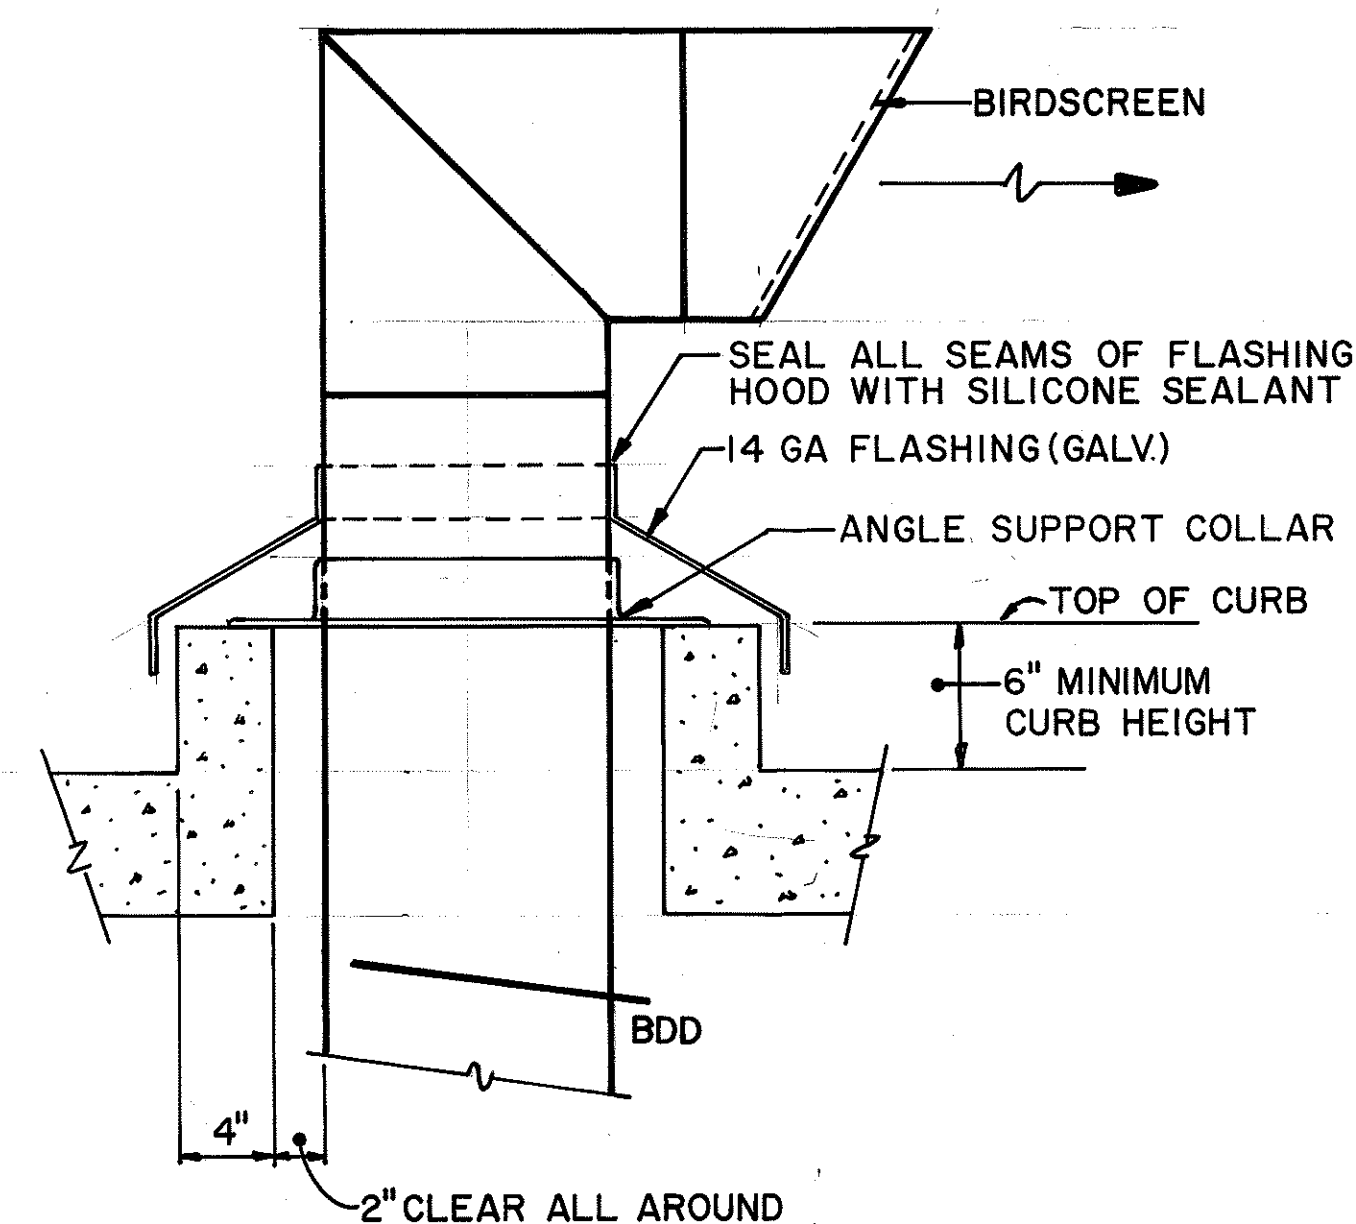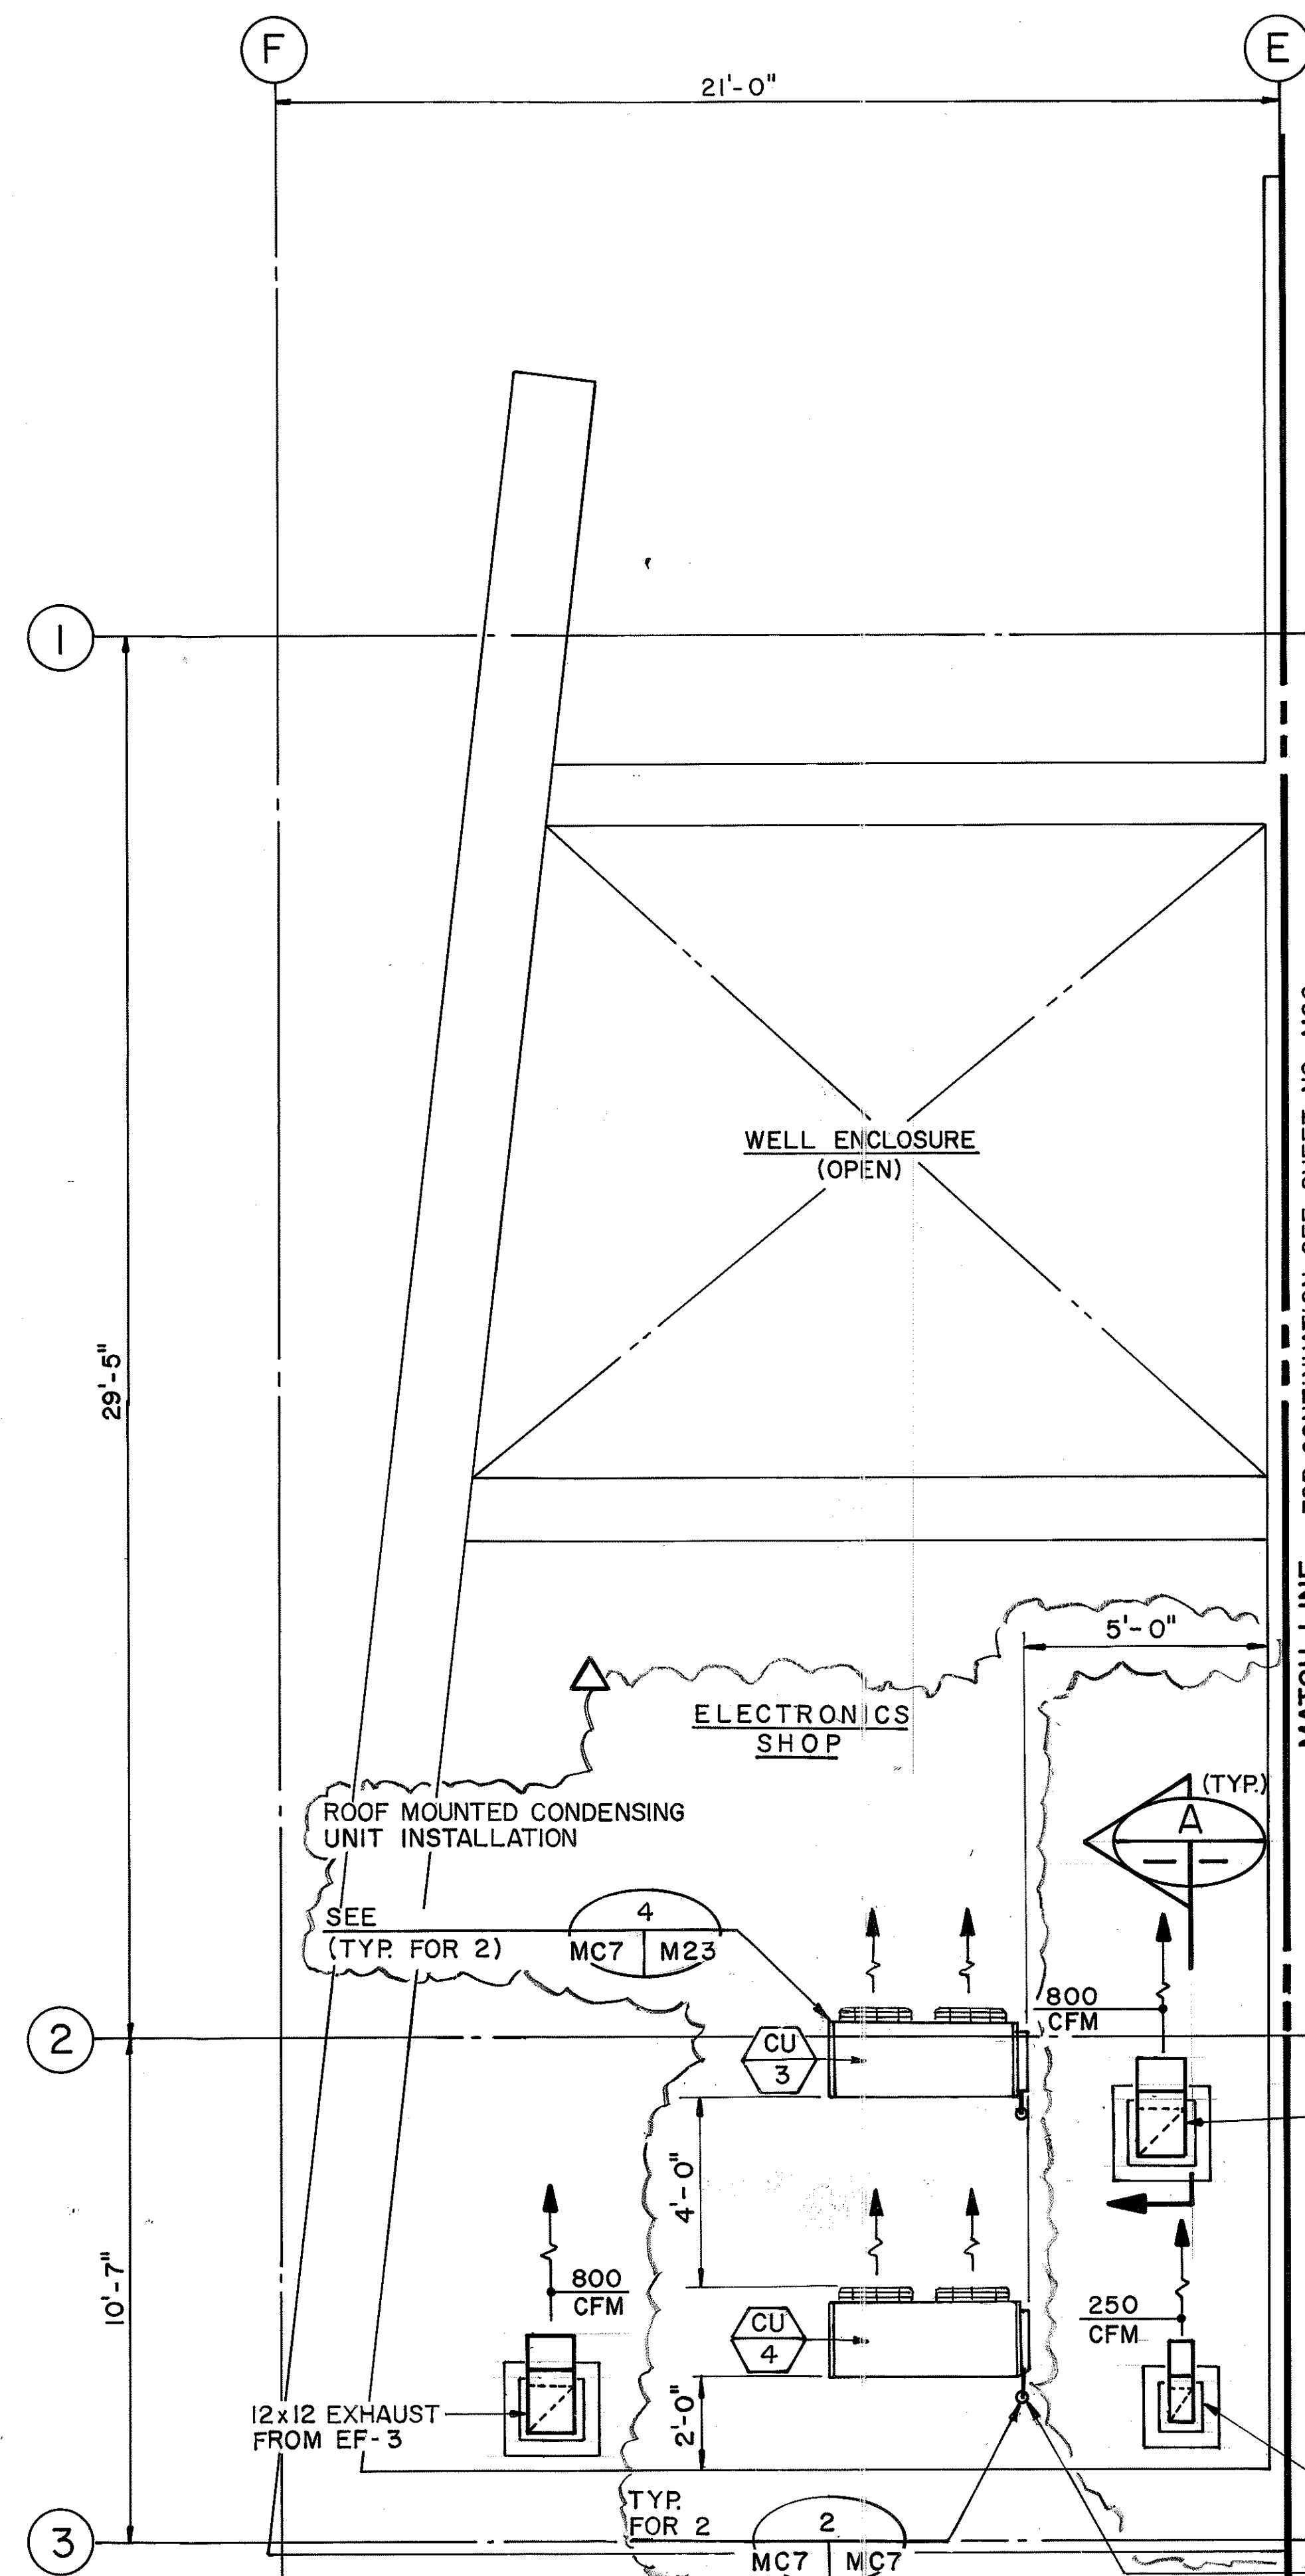

NOTES:
1. FOR LEGEND AND GENERAL NOTES REFER TO SHEET NO. M1.

SURVEY PLOTTED BY	DATE
PLAN	01/12/90
DRAWN BY	D. E. DRYDEN
TRACED BY	D. E. DRYDEN
NOTE BOOK	01/04/90
QUANTITIES BY	J. N. QUE
CHECKED BY	06/01/90


LEVEL 2 PARTIAL PLAN - 4
SCALE: 3/8"=1'-0"

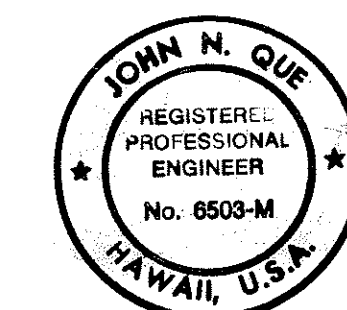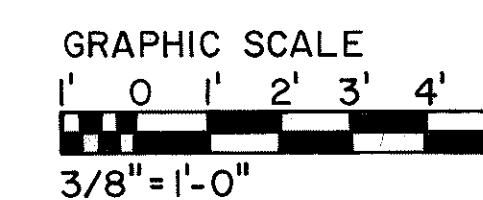

THIS WORK WAS PREPARED BY ME OR UNDER MY SUPERVISION
John N. Que




11/23/94	REV. PER DCN 66-054
1/12/94	DELETED DETAIL '1' PER DCN 66-030
DATE	REVISION
STATE OF HAWAII DEPARTMENT OF TRANSPORTATION HIGHWAYS DIVISION HVAC - LEVEL 2 PARTIAL PLAN, SECTIONS & DETAILS CONTROL BUILDING INTERSTATE ROUTE H-3 F.A.I. PROJ. NO. I-H3-1 (66)	
SCALE: 3/8"=1'-0" DATE: APR 1992 SHEET NO. MC7 OF 19 SHEETS	

FED. ROAD DIST. NO.	STATE	FED. AID PROJ. NO.	FISCAL YEAR	SHEET NO.	TOTAL SHEETS
HAWAII	HAW.	1-H3-1(66)	1992	62	440

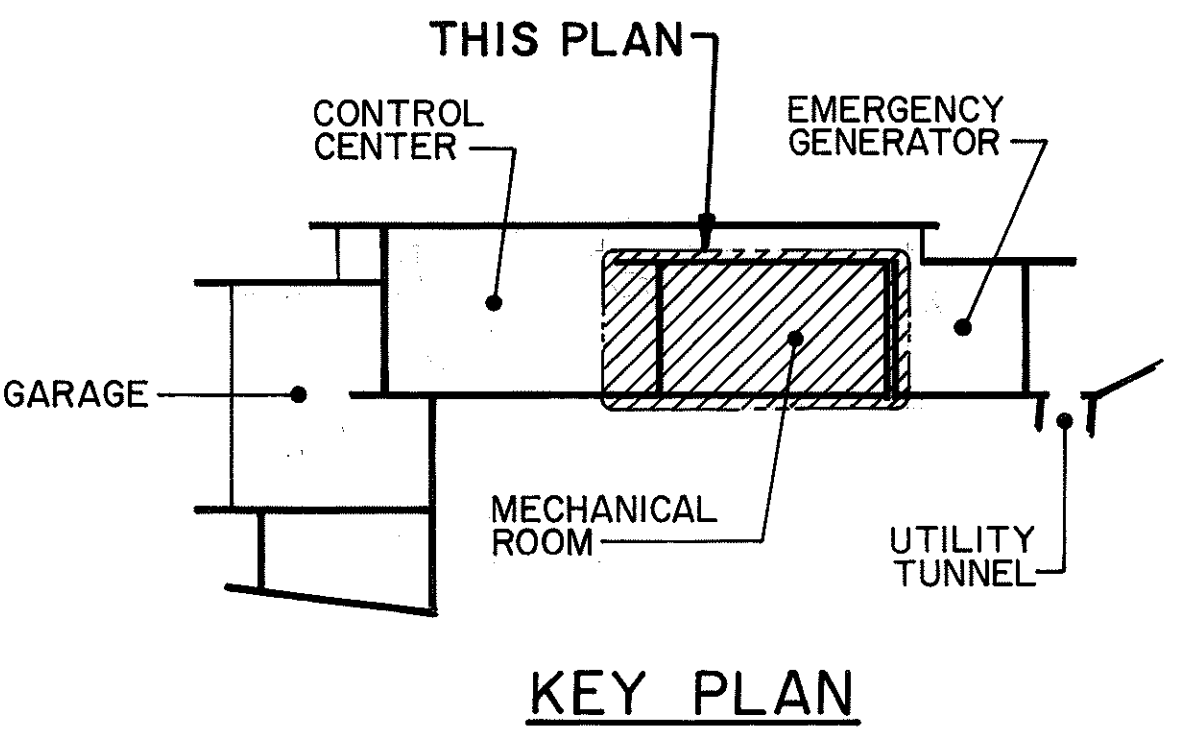

- NOTES:**
1. FOR BUILDING AIR CONDITIONING UNIT SCHEDULE REFER TO SHEET NO. M3
 2. FOR FAN SCHEDULE REFER TO SHEET NO. M5.
 3. FOR CONDENSING UNIT SCHEDULE REFER TO SHEET NO. M3

SURVEY PLOTTED BY	DATE
DRAWN BY	04/24/90
TRACED BY	
NOTED BY	01/08/90
CHECKED BY	06/18/90
ORIGINAL PLAN	
NOTE BOOK	
No.	

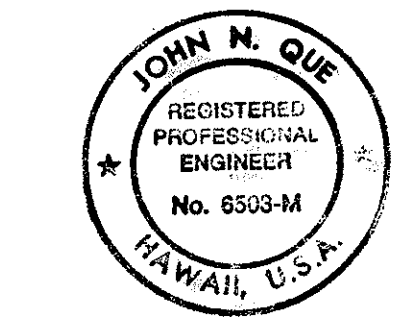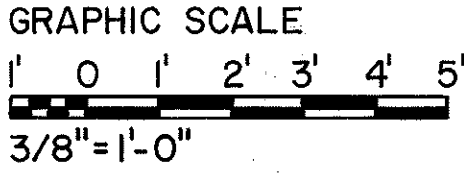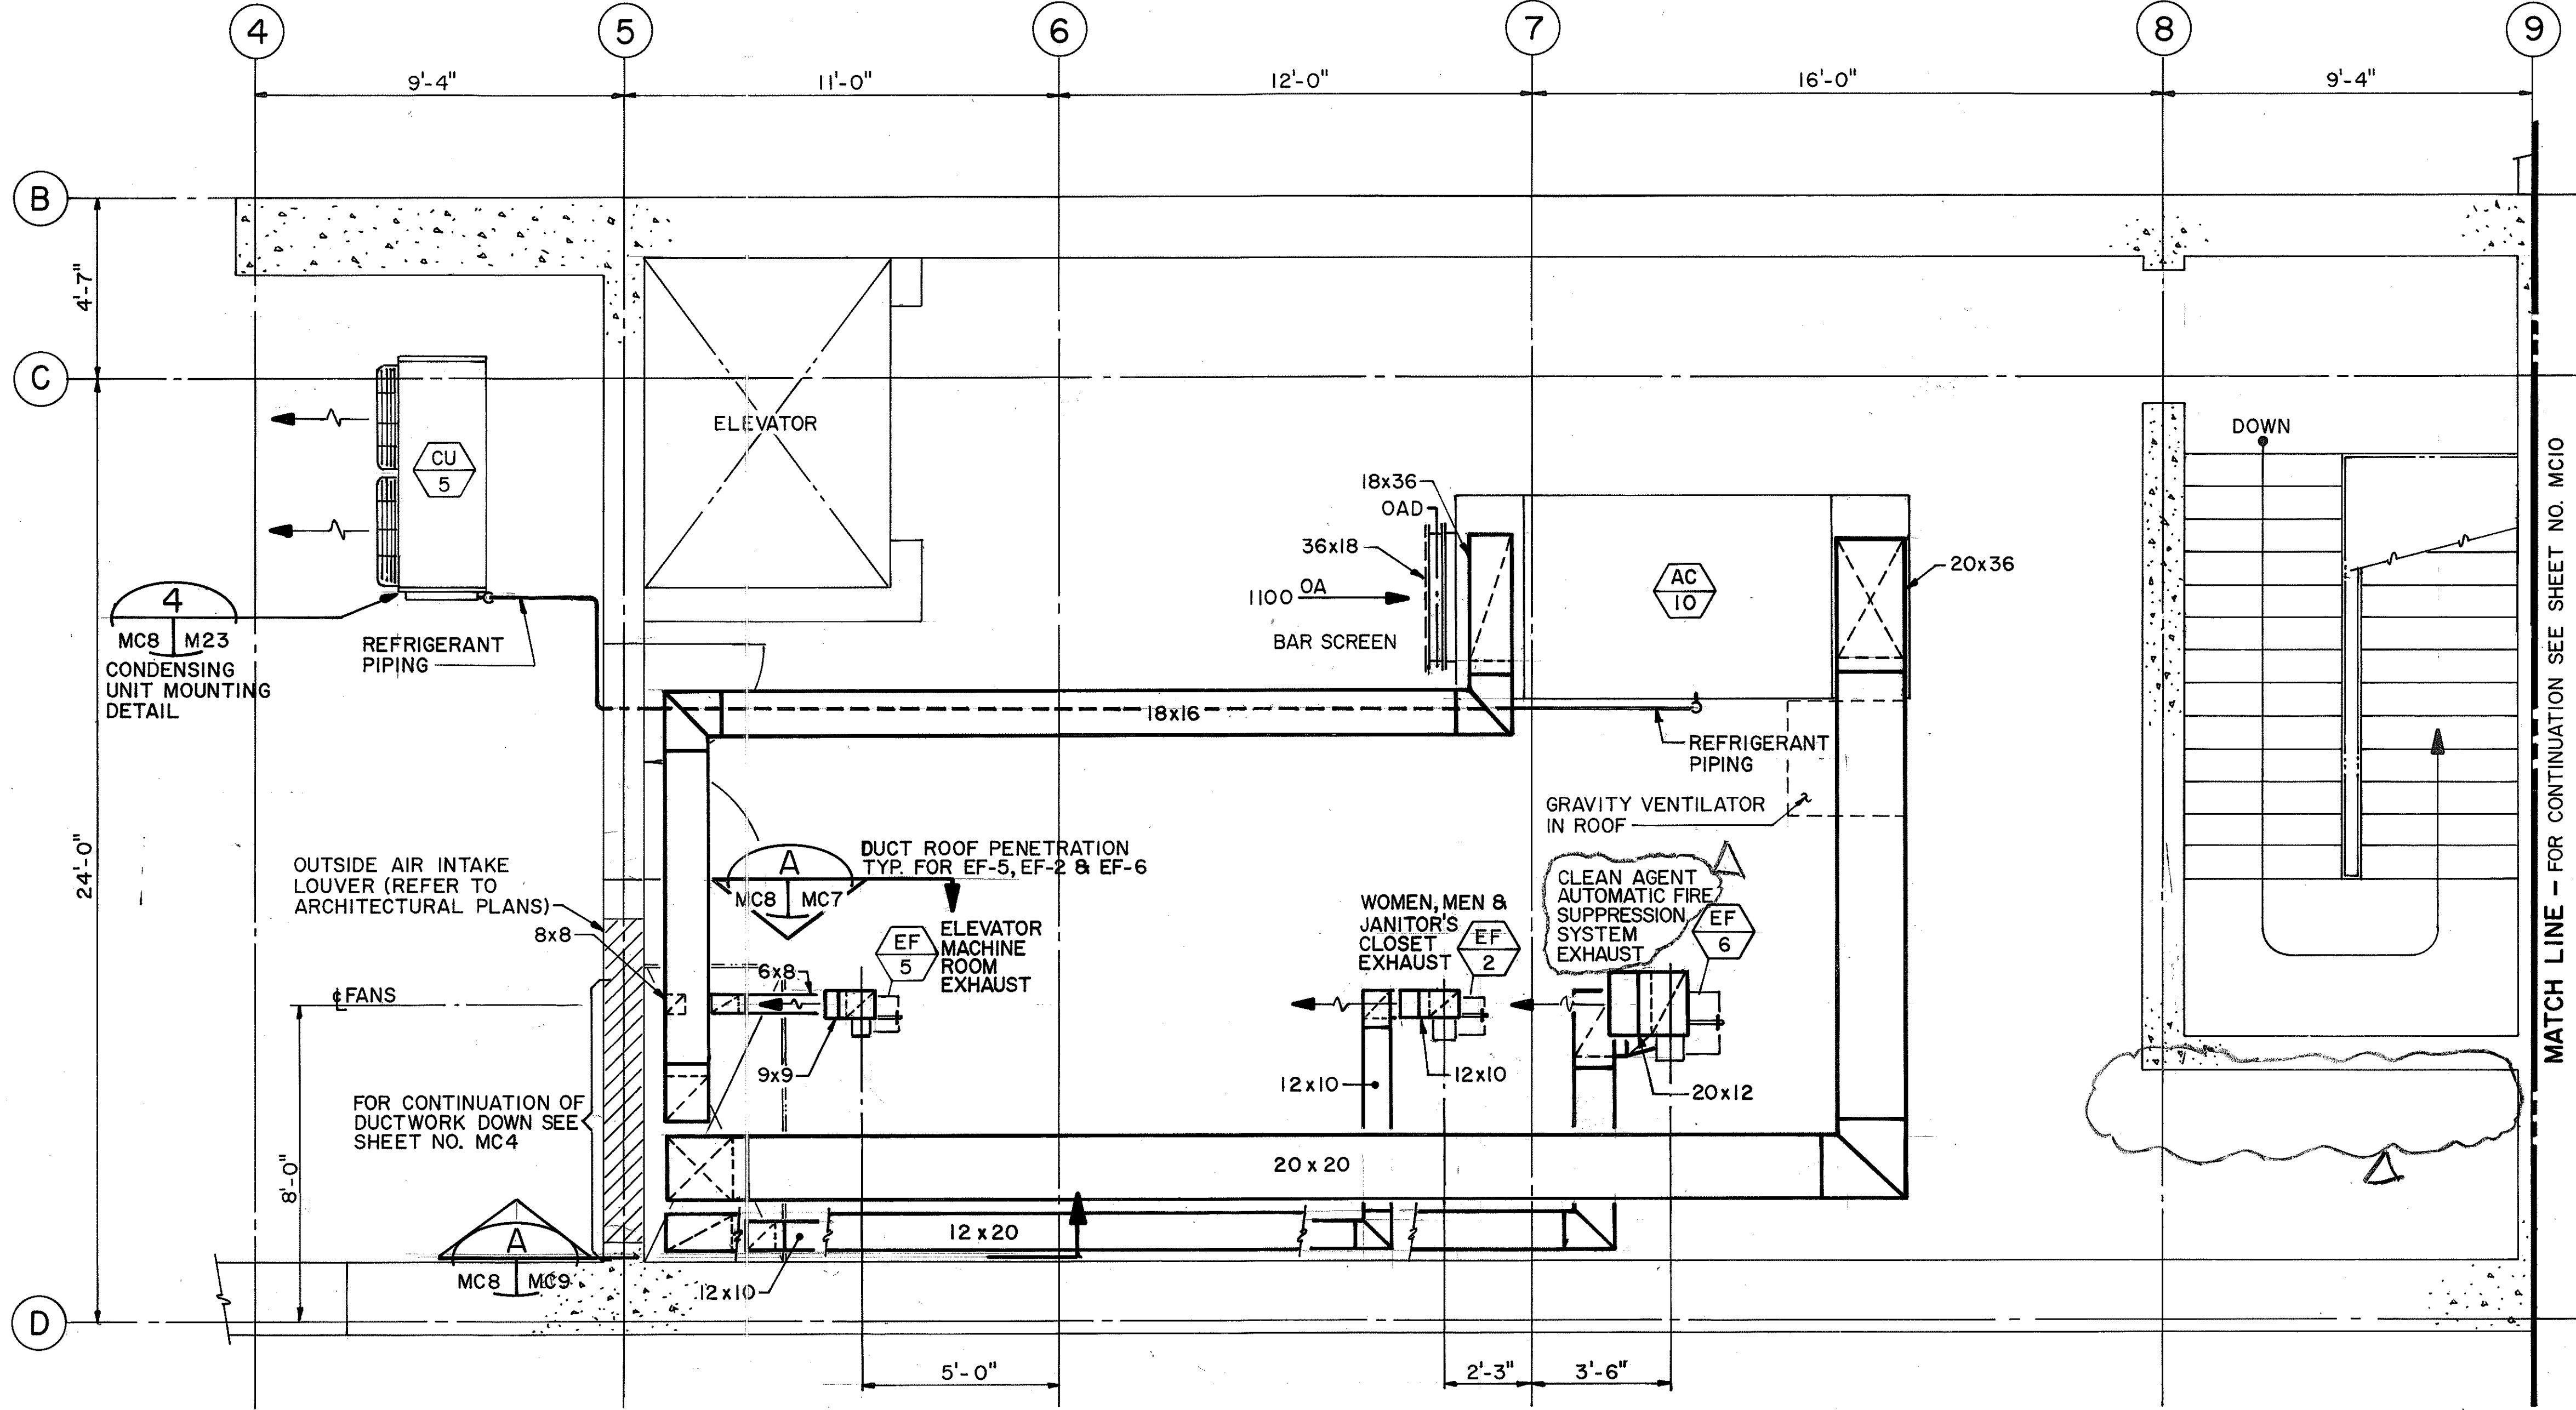

THIS WORK WAS PREPARED BY ME OR UNDER MY SUPERVISION

John N. Que


1/25/94	REV. PER DCN 66-034
1/18/94	REV. DETAIL NO. & REF. PER DCN 66-030
DATE	REVISION
STATE OF HAWAII DEPARTMENT OF TRANSPORTATION HIGHWAYS DIVISION HVAC - LEVEL 3 MECHANICAL ROOM PLAN CONTROL BUILDING INTERSTATE ROUTE H-3 F.A.I. PROJ. NO. 1-H3-1 (66)	
SCALE: 3/8"=1'-0"	DATE: APR 1992
SHEET NO. MC8 OF 19 SHEETS	

Diagram illustrating the layout of the roof structure, showing the following components:

- CONTROL CENTER ROOF
- EMERGENCY GENERATOR ROOF
- MECHANICAL ROOM
- GARAGE ROOF
- THIS PLAN (indicated by an arrow pointing to the Control Center Roof area)

NOTES:

1. FOR LEGEND AND GENERAL NOTES REFER TO SHEET NO. M1
2. FOR CONDENSING UNIT SCHEDULE REFER TO SHEET NO. M3

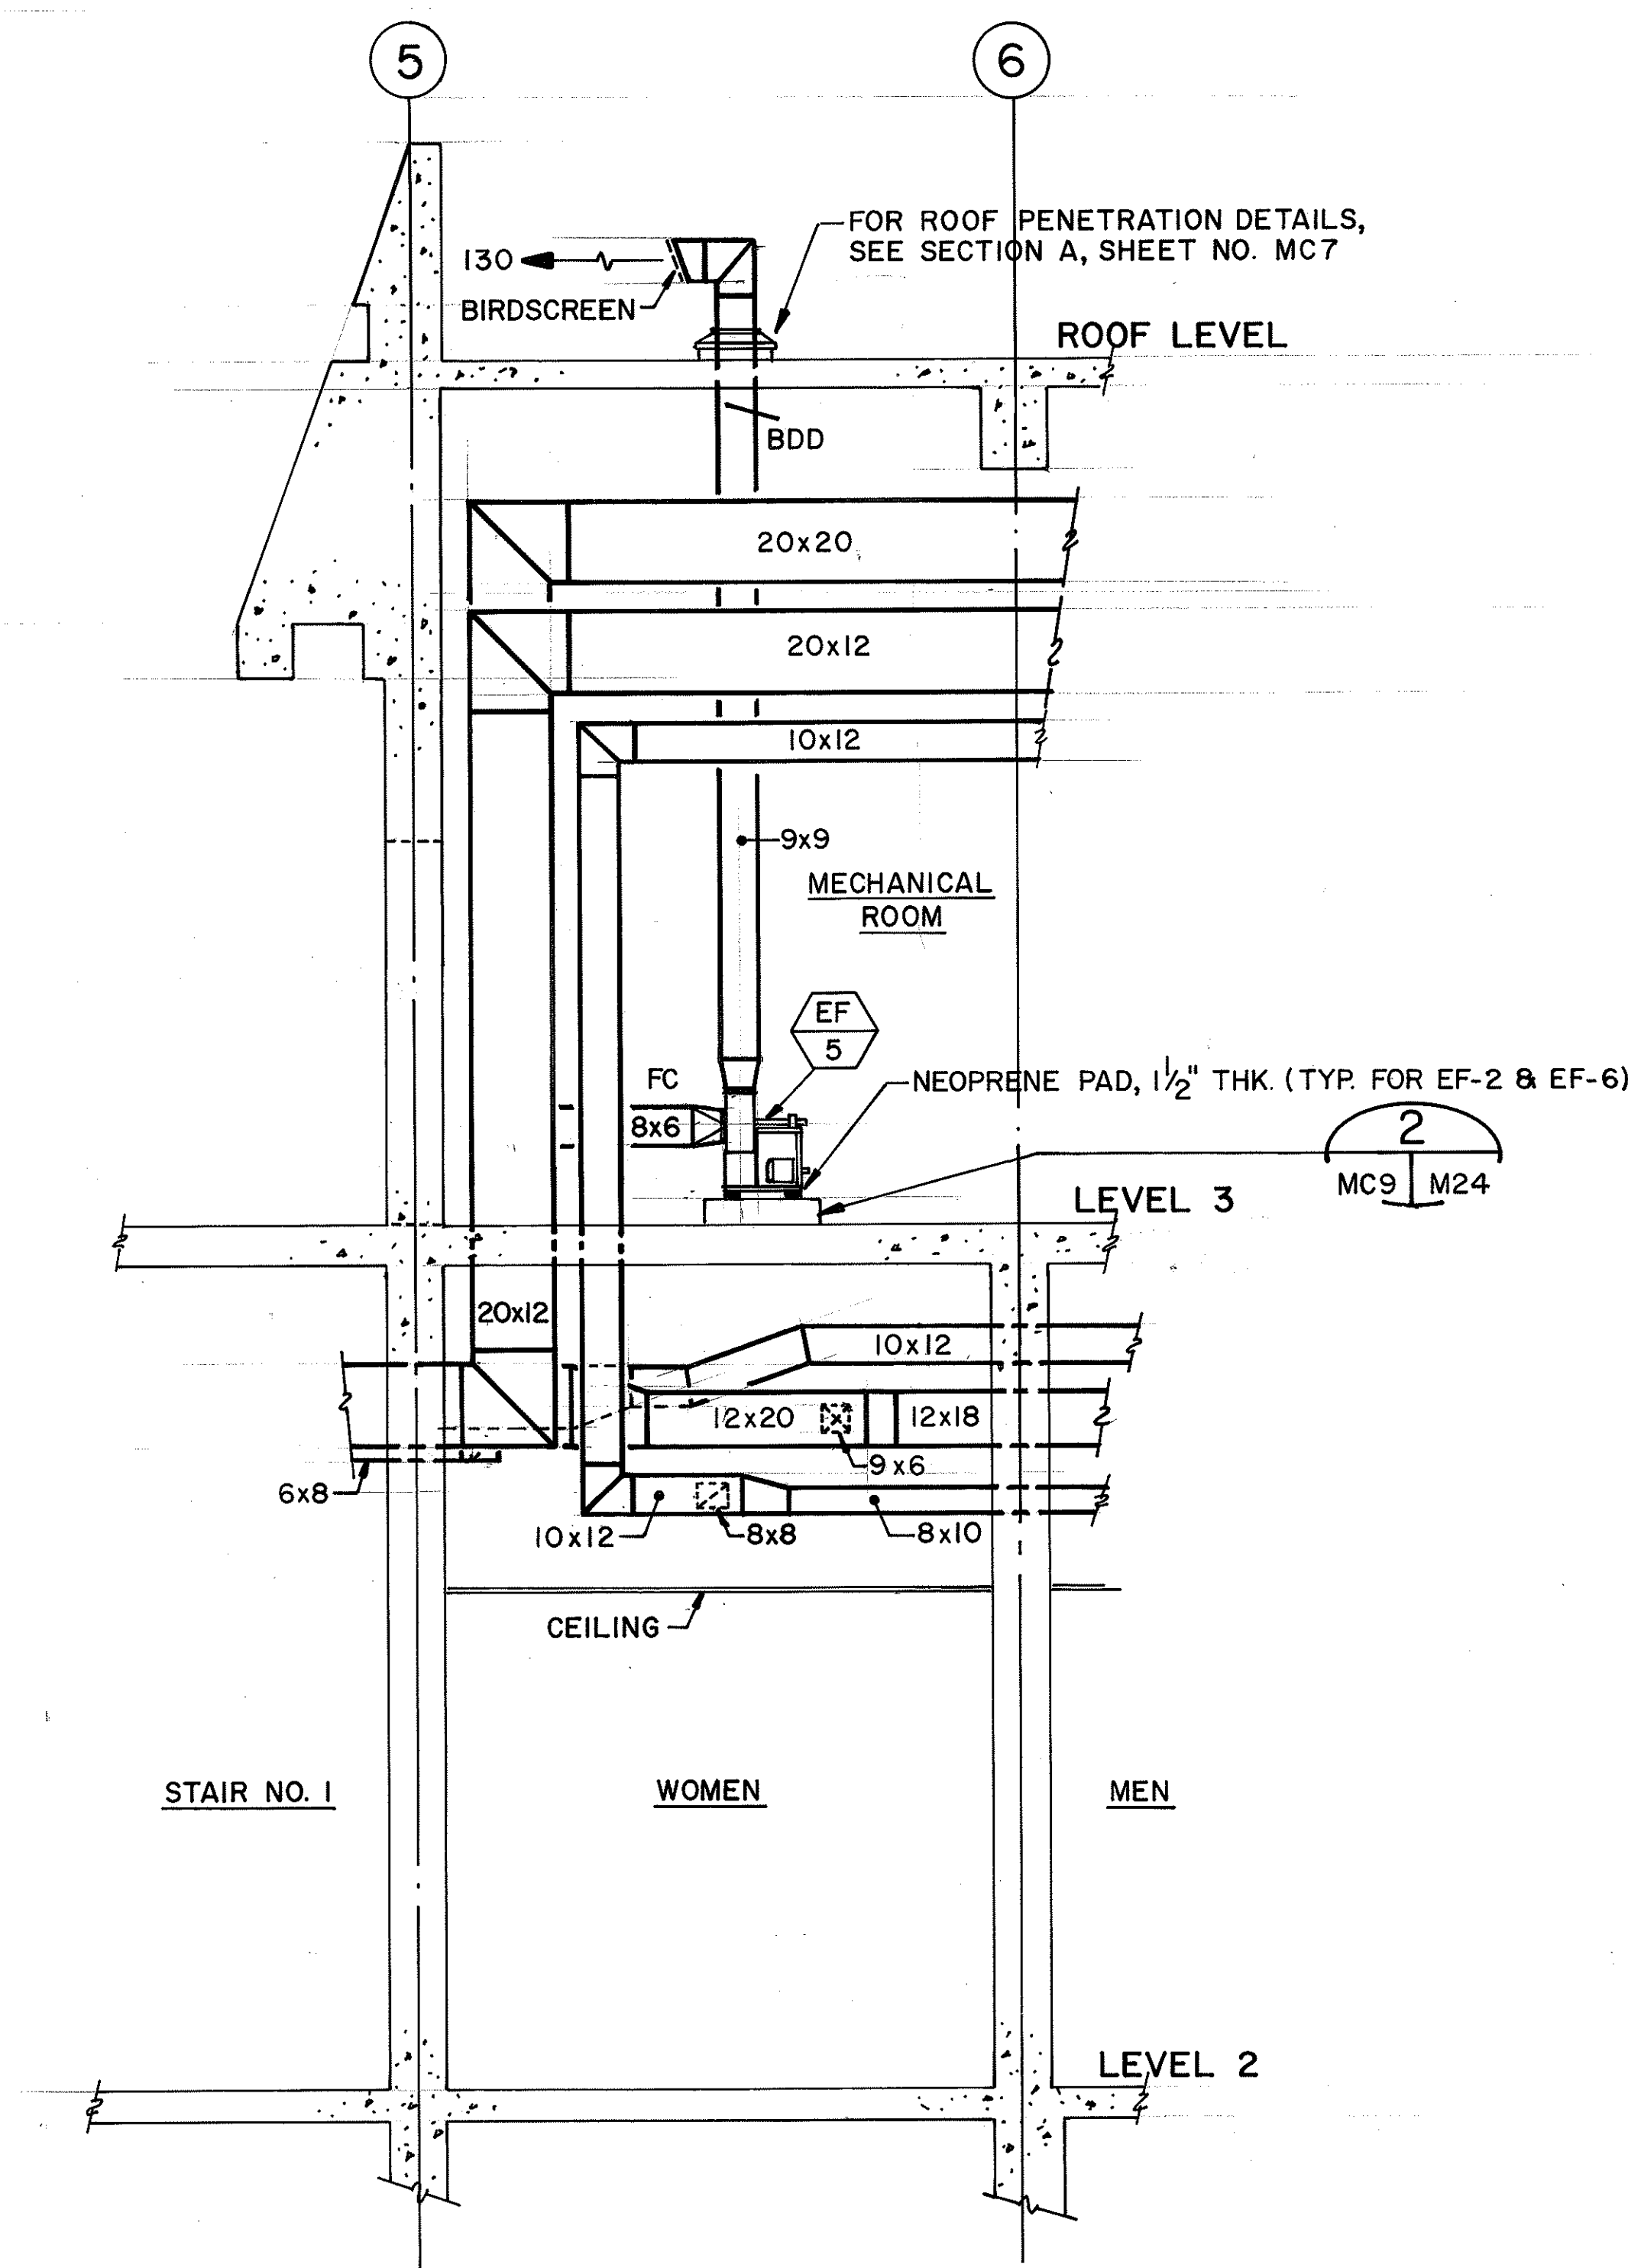



SECTION

3/8" = 1'-0"

MC4
MC8

A

MC9

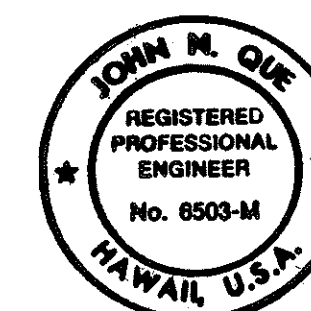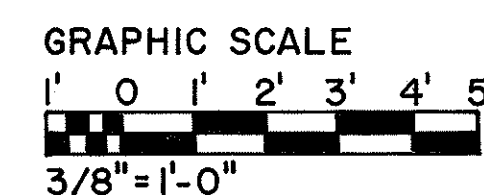

THIS WORK WAS PREPARED BY ME
OR UNDER MY SUPERVISION

John Doe

11/23/94	REV. PER DCN 66-054
1/12/94	REV. CU TAG NO'S AND DETAIL REFERENCE PER DCN 66-030
DATE	REVISION

STATE OF HAWAII
DEPARTMENT OF TRANSPORTATION
HIGHWAYS DIVISION

HVAC — LEVEL 3
PARTIAL PLAN & SECTION
CONTROL BUILDING
INTERSTATE ROUTE H-3
F.A.I. PROJ. NO. I-H3-1 (66)


SCALE: 3/8"=1'-0" DATE: APR 1992

SHEET NO. MC9 OF 19 SHEETS

ORIGINAL PLAN	SURVEY PLOTTED BY	DATE
	DRAWN BY	
	DESIGNED BY	
	QUANTITIES BY	
	CHECKED BY	
No.		


A schematic diagram of the station layout. It shows a horizontal corridor with several rooms branching off. From left to right, the rooms are: Garage, Control Center, Mechanical Room, and Emergency Generator. A Utility Tunnel is located below the Mechanical Room. The Emergency Generator is a large rectangular room with diagonal hatching. The Utility Tunnel is a narrow vertical passage. The diagram is labeled with the following text: CONTROL CENTER, EMERGENCY GENERATOR THIS PLAN, GARAGE, MECHANICAL ROOM, and UTILITY TUNNEL.

NOTES:

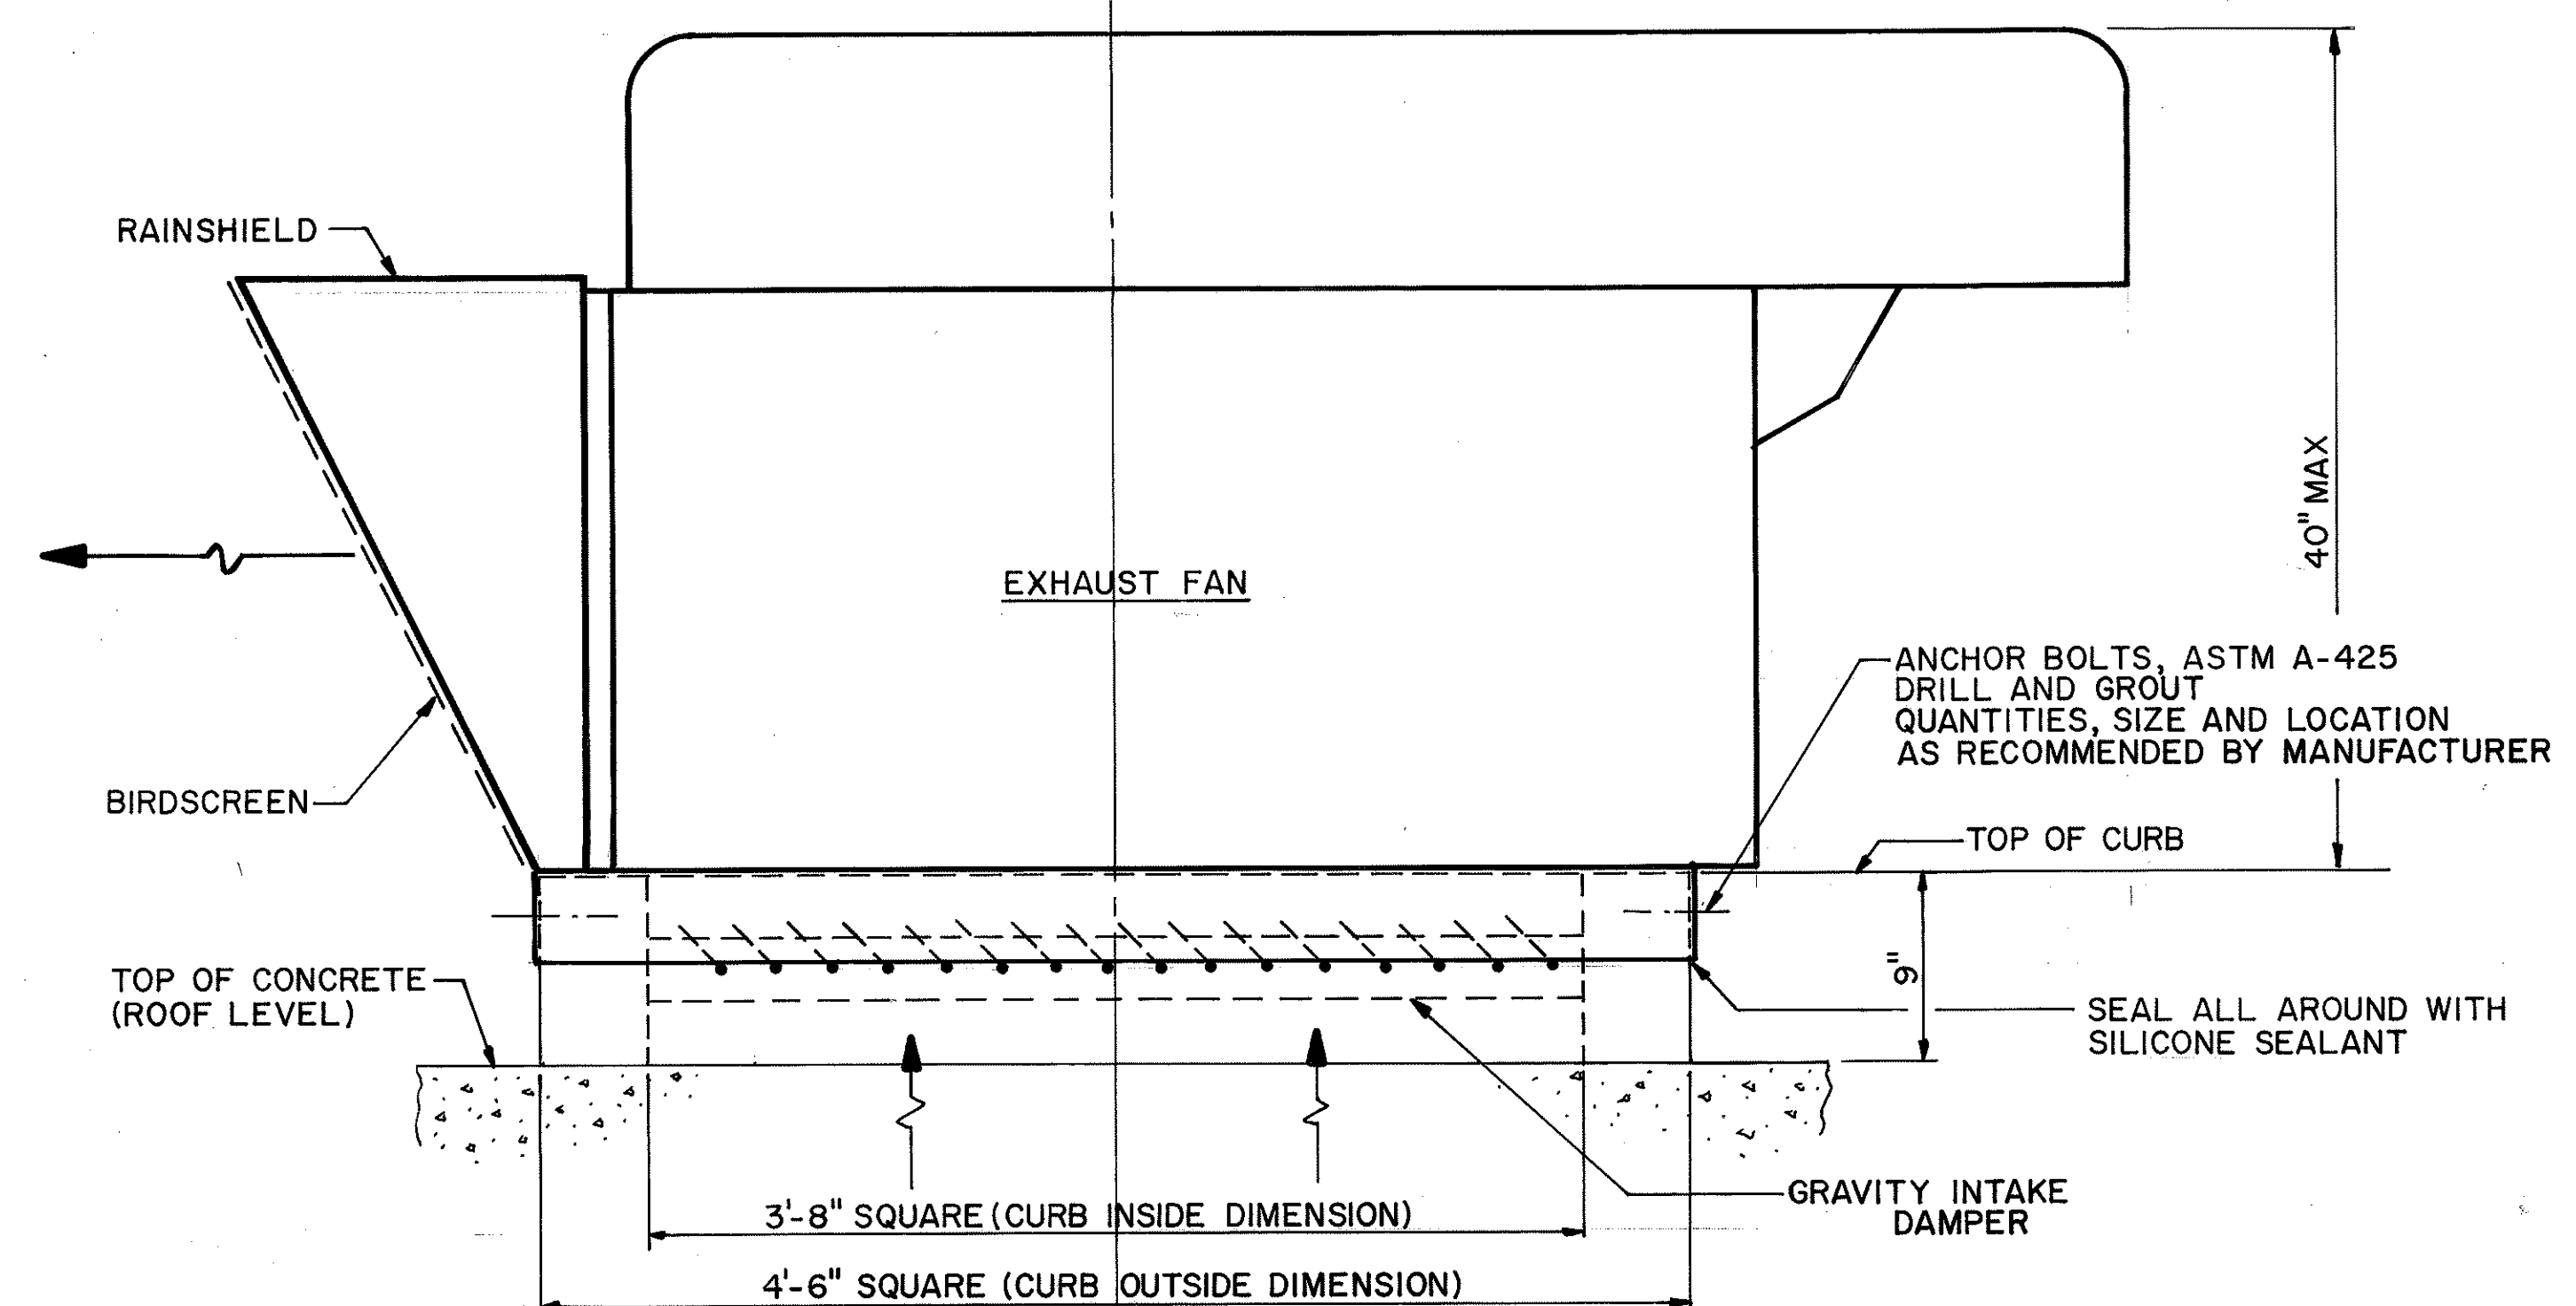

A diagram of a cell with a nucleus labeled 'A' and two minus signs representing negative charges.

GRAPHIC SCALES

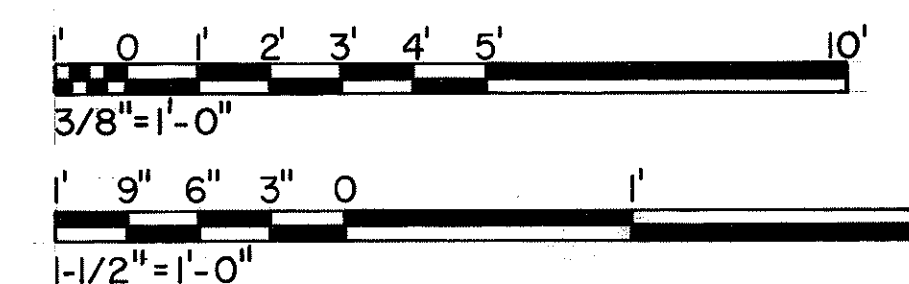

John W. Gies

STATE OF HAWAII
DEPARTMENT OF TRANSPORTATION
HIGHWAYS DIVISION

HVAC — EMERGENCY GENERATOR

ROOF PLAN & SECTION

CONTROL BUILDING

INTERSTATE ROUTE H-3
F.A.I. PROJ. NO. I-H3-1 (66)

SCALE : AS NOTED DATE : APR 1992

SHEET NO. MCIO OF 19 SHEETS

STATE OF HAWAII
DEPARTMENT OF TRANSPORTATION
HIGHWAYS DIVISION

HVAC — EMERGENCY GENERATOR

ROOF PLAN & SECTION

CONTROL BUILDING

INTERSTATE ROUTE H-3
F.A.I. PROJ. NO. I-H3-1 (66)

SCALE : AS NOTED DATE : APR 1992

SHEET NO. MCIO OF 19 SHEETS


SCALE : AS NOTED DATE : APR 1992

SHEET NO. MC10 OF 19 SHEETS


64

ORIGINAL PLAN	SURVEY PLOTTED BY _____ DATE _____
	DRAWN BY <u>D. E. DRYDEN</u> *
	DESIGNED BY _____ *
NOTE BOOK	TRACED BY <u>D. E. DRYDEN</u> *
	QUANTITIES BY _____ *
	CHECKED BY <u>J. N. QUE</u> *
No. _____	01/24/90
	01/10/90
	06/01/90


FED. ROAD DIST. NO.	STATE	FED. AID PROJ. NO.	FISCAL YEAR	SHEET NO.	TOTAL SHEETS
HAWAII	HAW.	1-H3-1(66)	1992	65	440

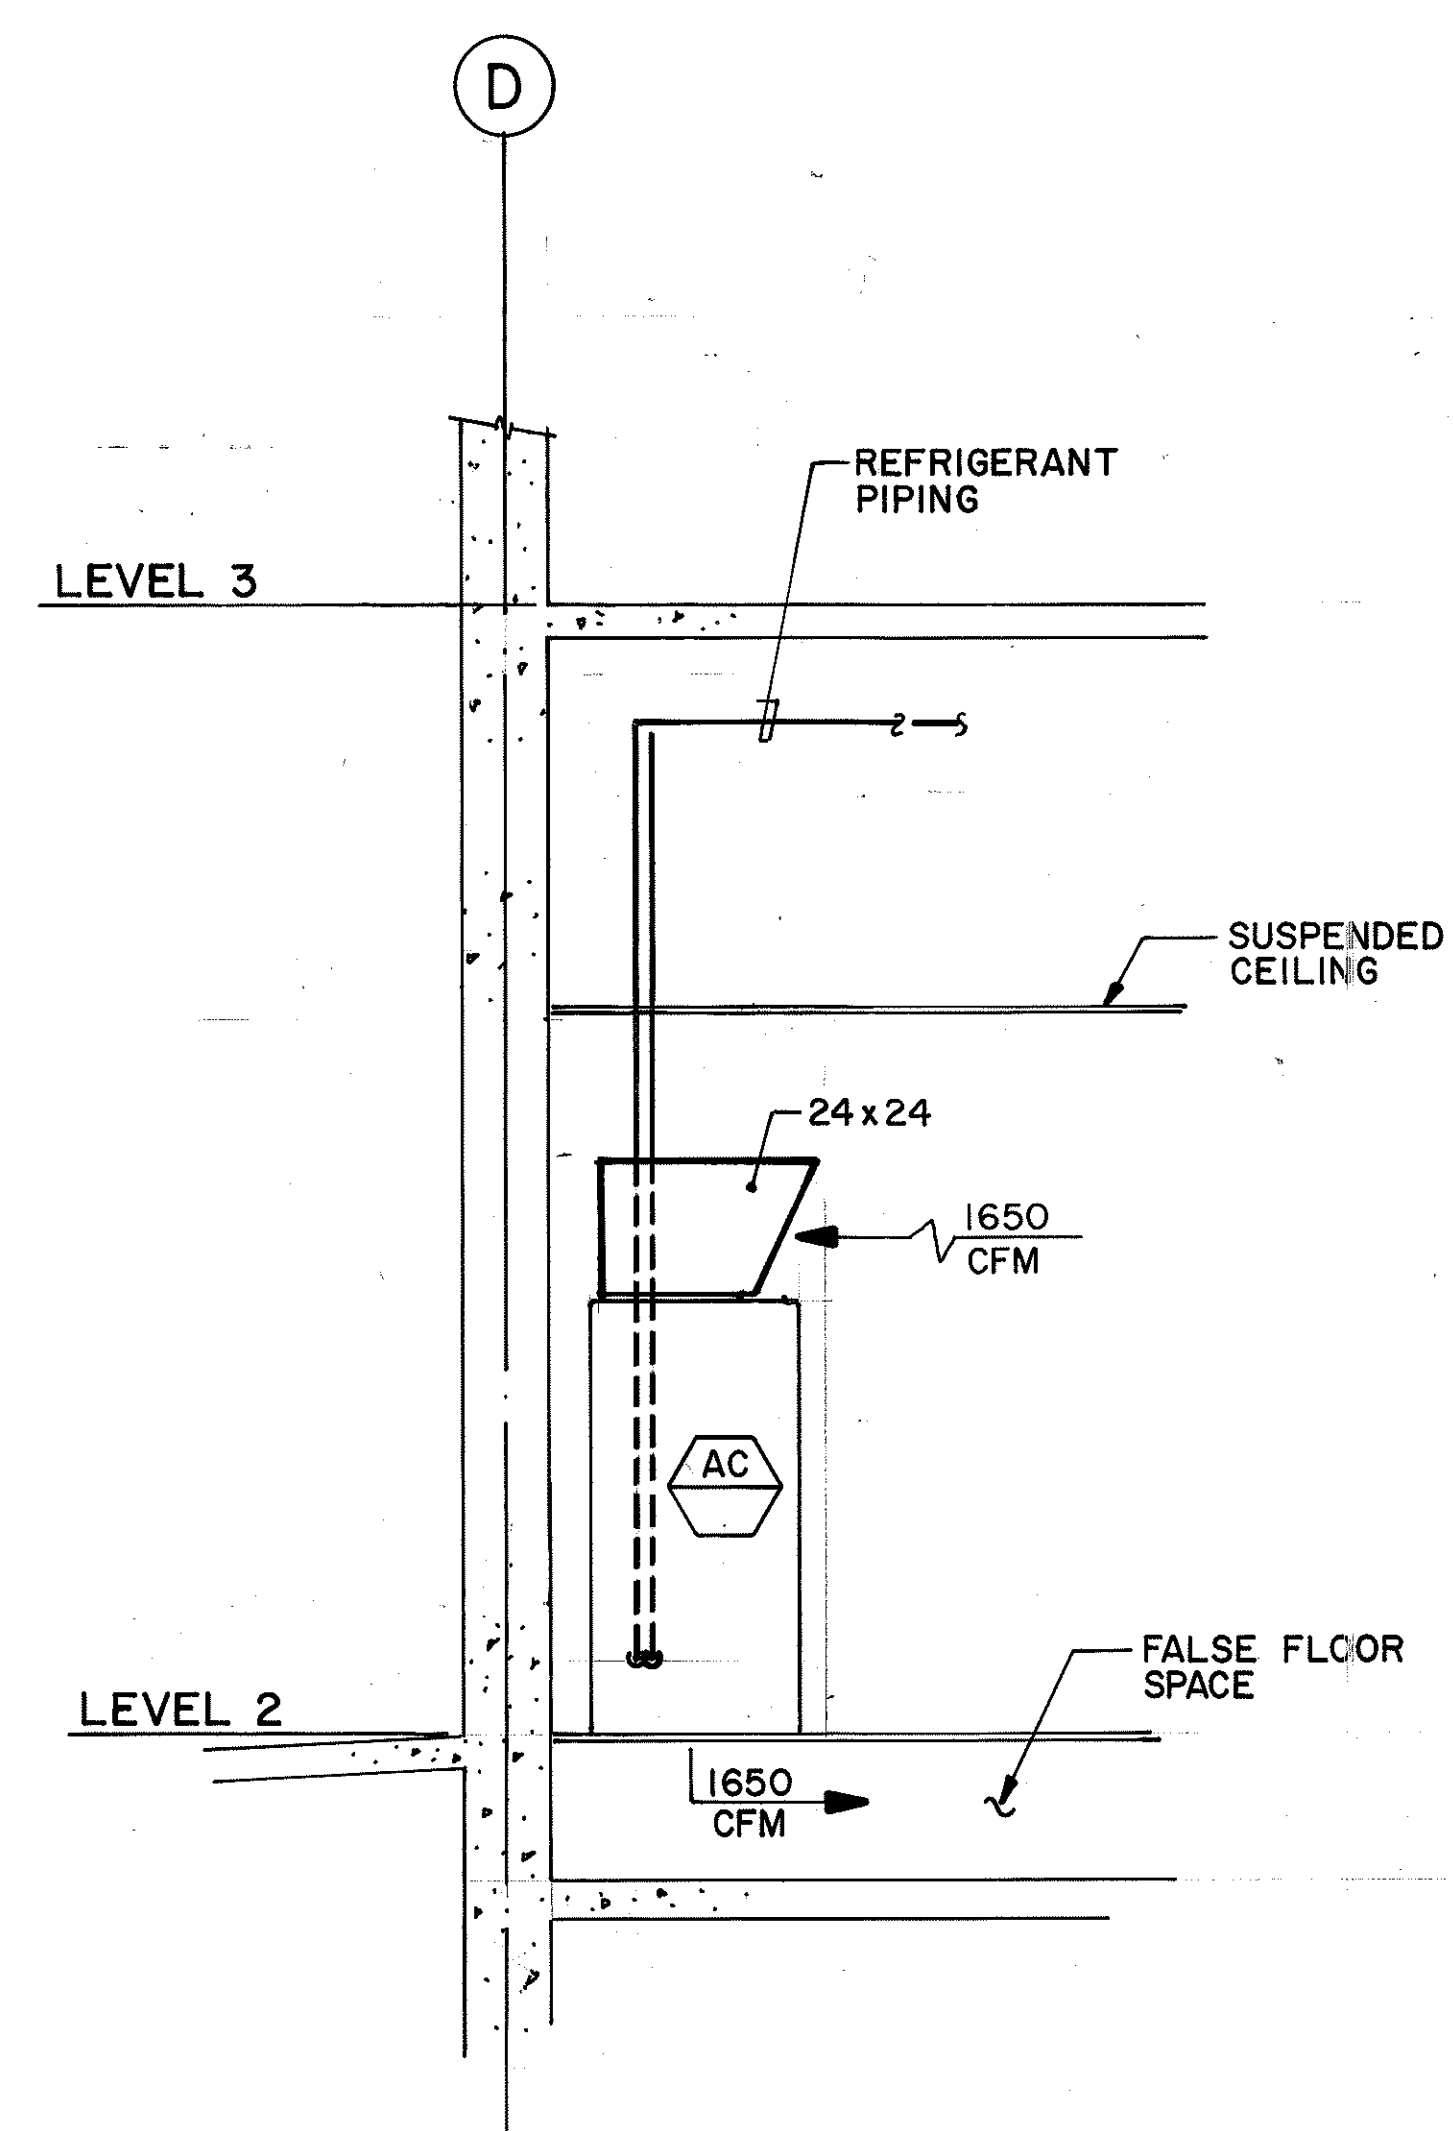


SECTION A
3/8"=1'-0" MC6 MC11

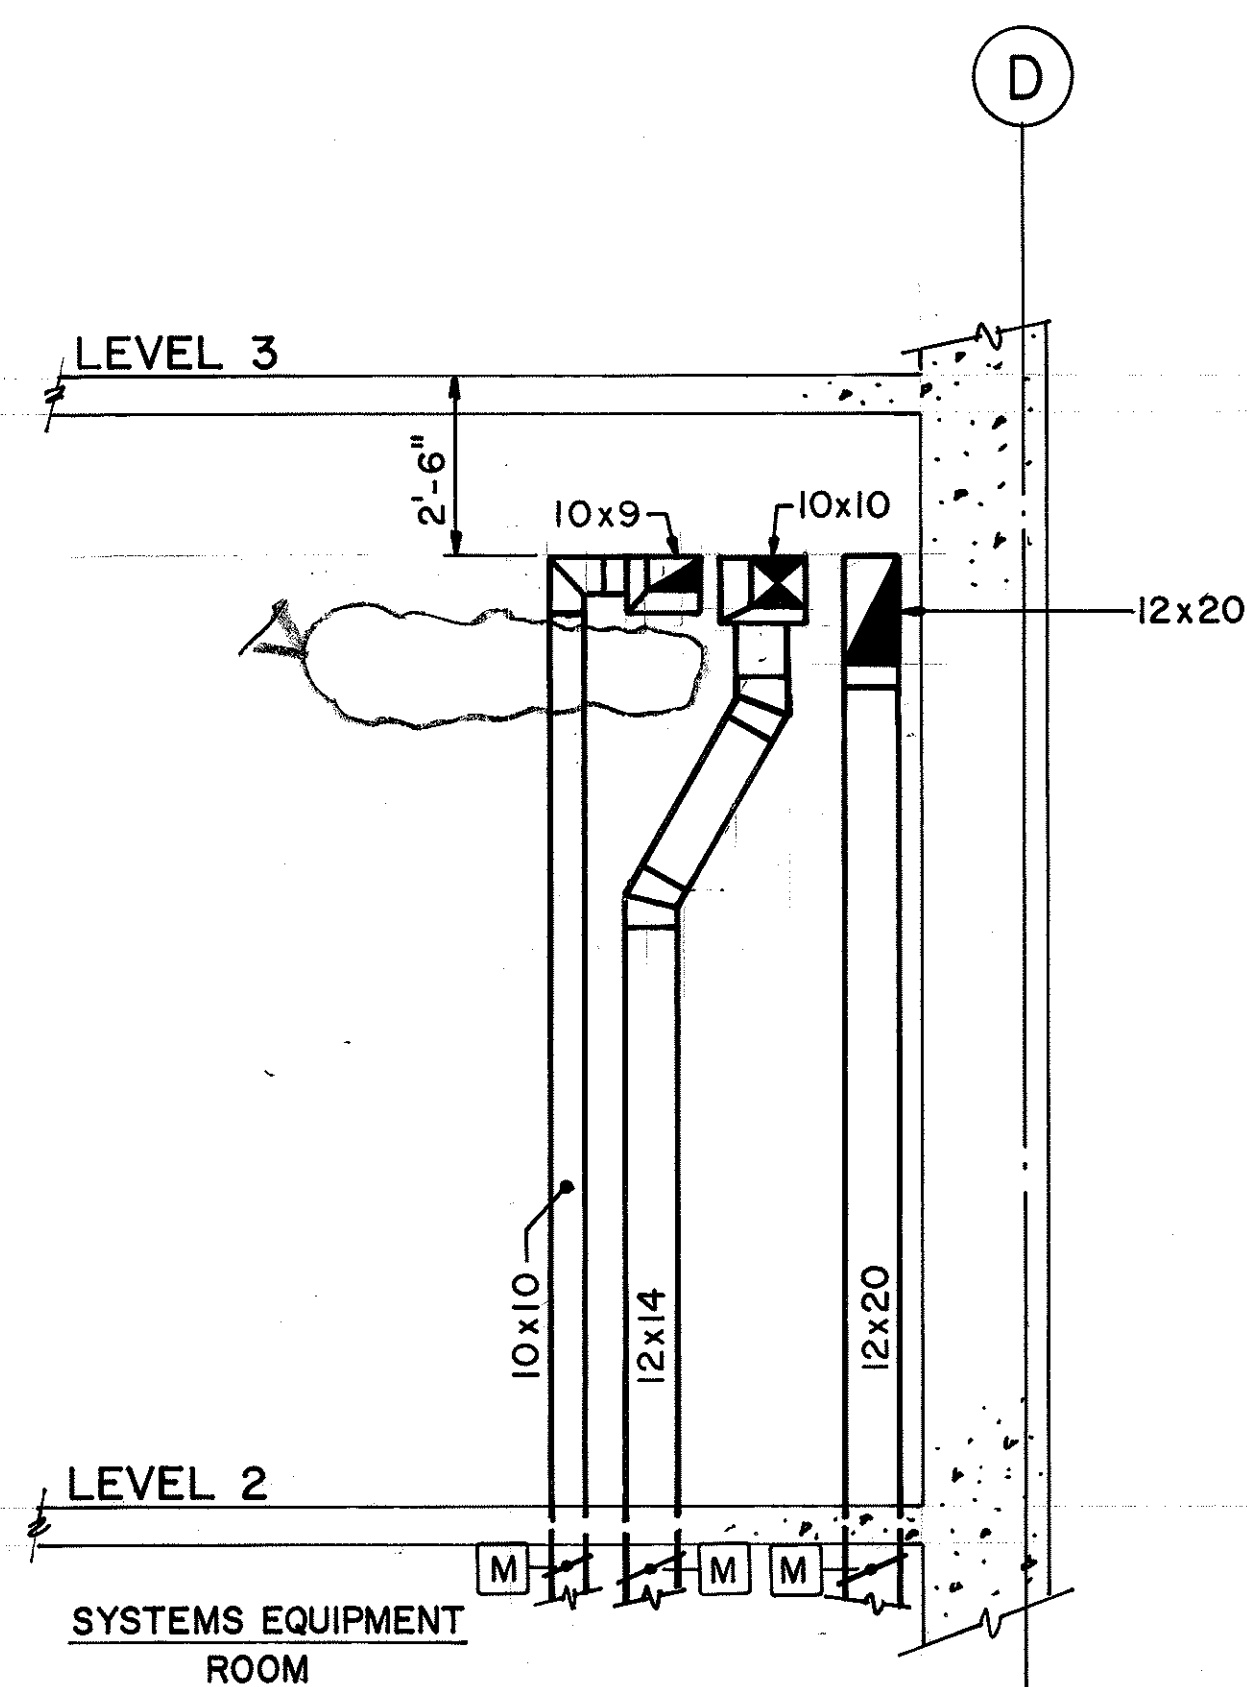



SECTION B
3/8"=1'-0" MC5 MC11

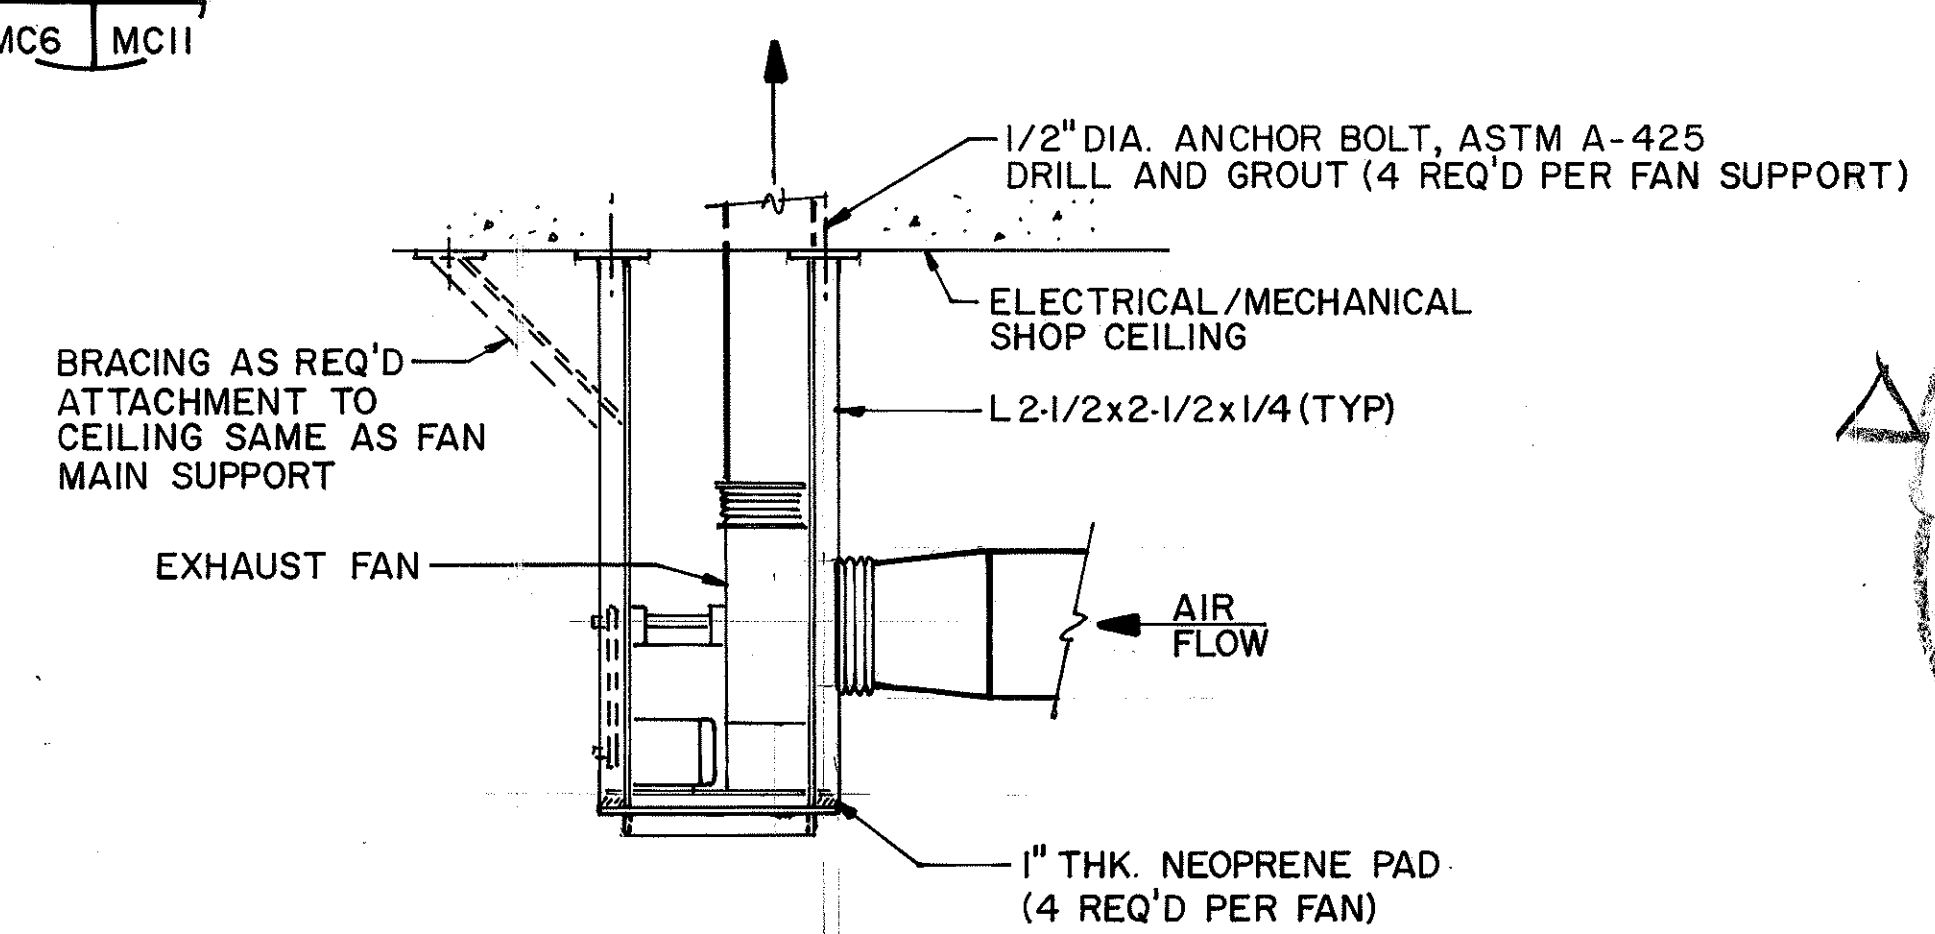

DETAIL I
NO SCALE MC3 MC11

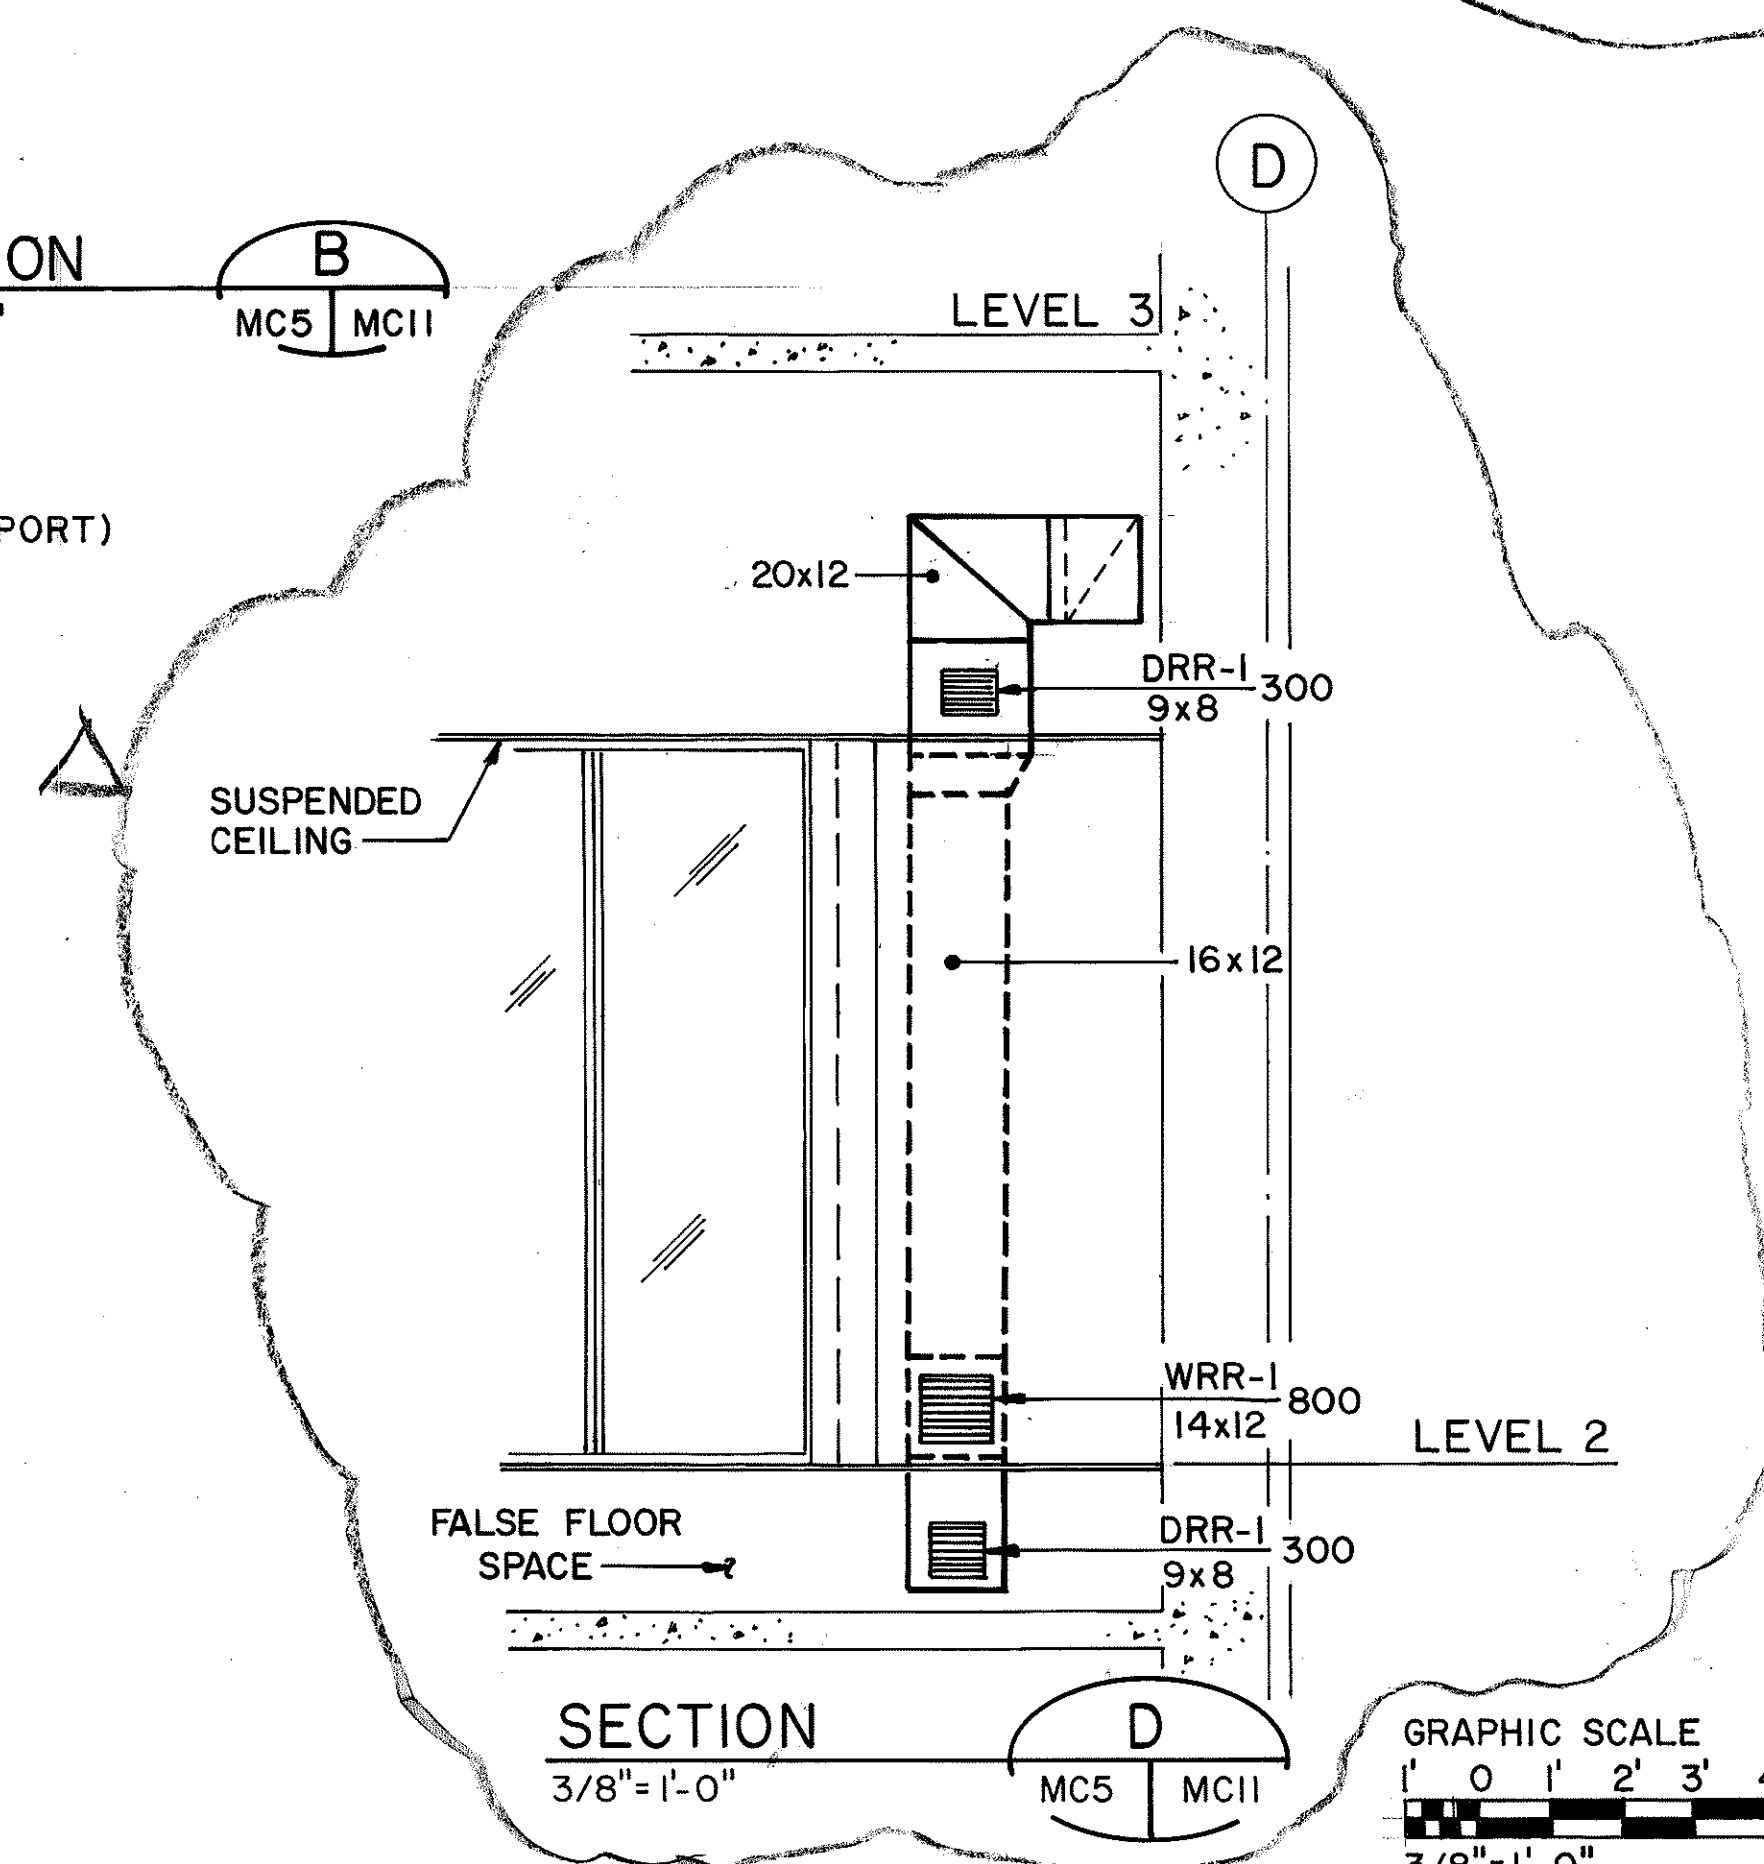

SECTION D
3/8"=1'-0" MC5 MC11

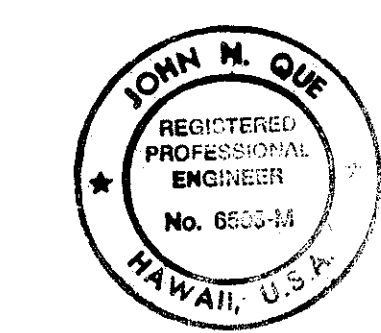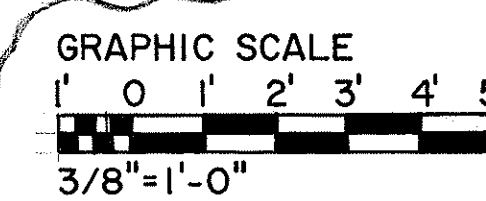


THIS WORK WAS PREPARED BY ME OR UNDER MY SUPERVISION
John M. Que

DATE	REVISION
12/16/94	REV. PER DCN 66-054A
1/19/94	REVISED SECTIONS 'A', 'B' & 'C' PER DCN 66-030
DATE	REVISION
STATE OF HAWAII DEPARTMENT OF TRANSPORTATION HIGHWAYS DIVISION HVAC SECTIONS & DETAIL CONTROL BUILDING INTERSTATE ROUTE H-3 F.A.I. PROJ. NO. 1-H3-1 (66)	
SCALE: 3/8"=1'-0" DATE: APR 1992 SHEET NO. MC11 OF 19 SHEETS	

SURVEY PLOTTED BY	DATE
DRAWN BY	04/11/90
DESIGNED BY	04/09/90
QUANTITIES BY	06/01/90
CHECKED BY	
ORIGINAL PLAN	
NOTE BOOK	
NO.	

FED. ROAD DIST. NO.	STATE	FED. AID PROJ. NO.	FISCAL YEAR	SHEET NO.	TOTAL SHEETS
HAWAII	HAW.	I-H3-I(66)	1992	66	440

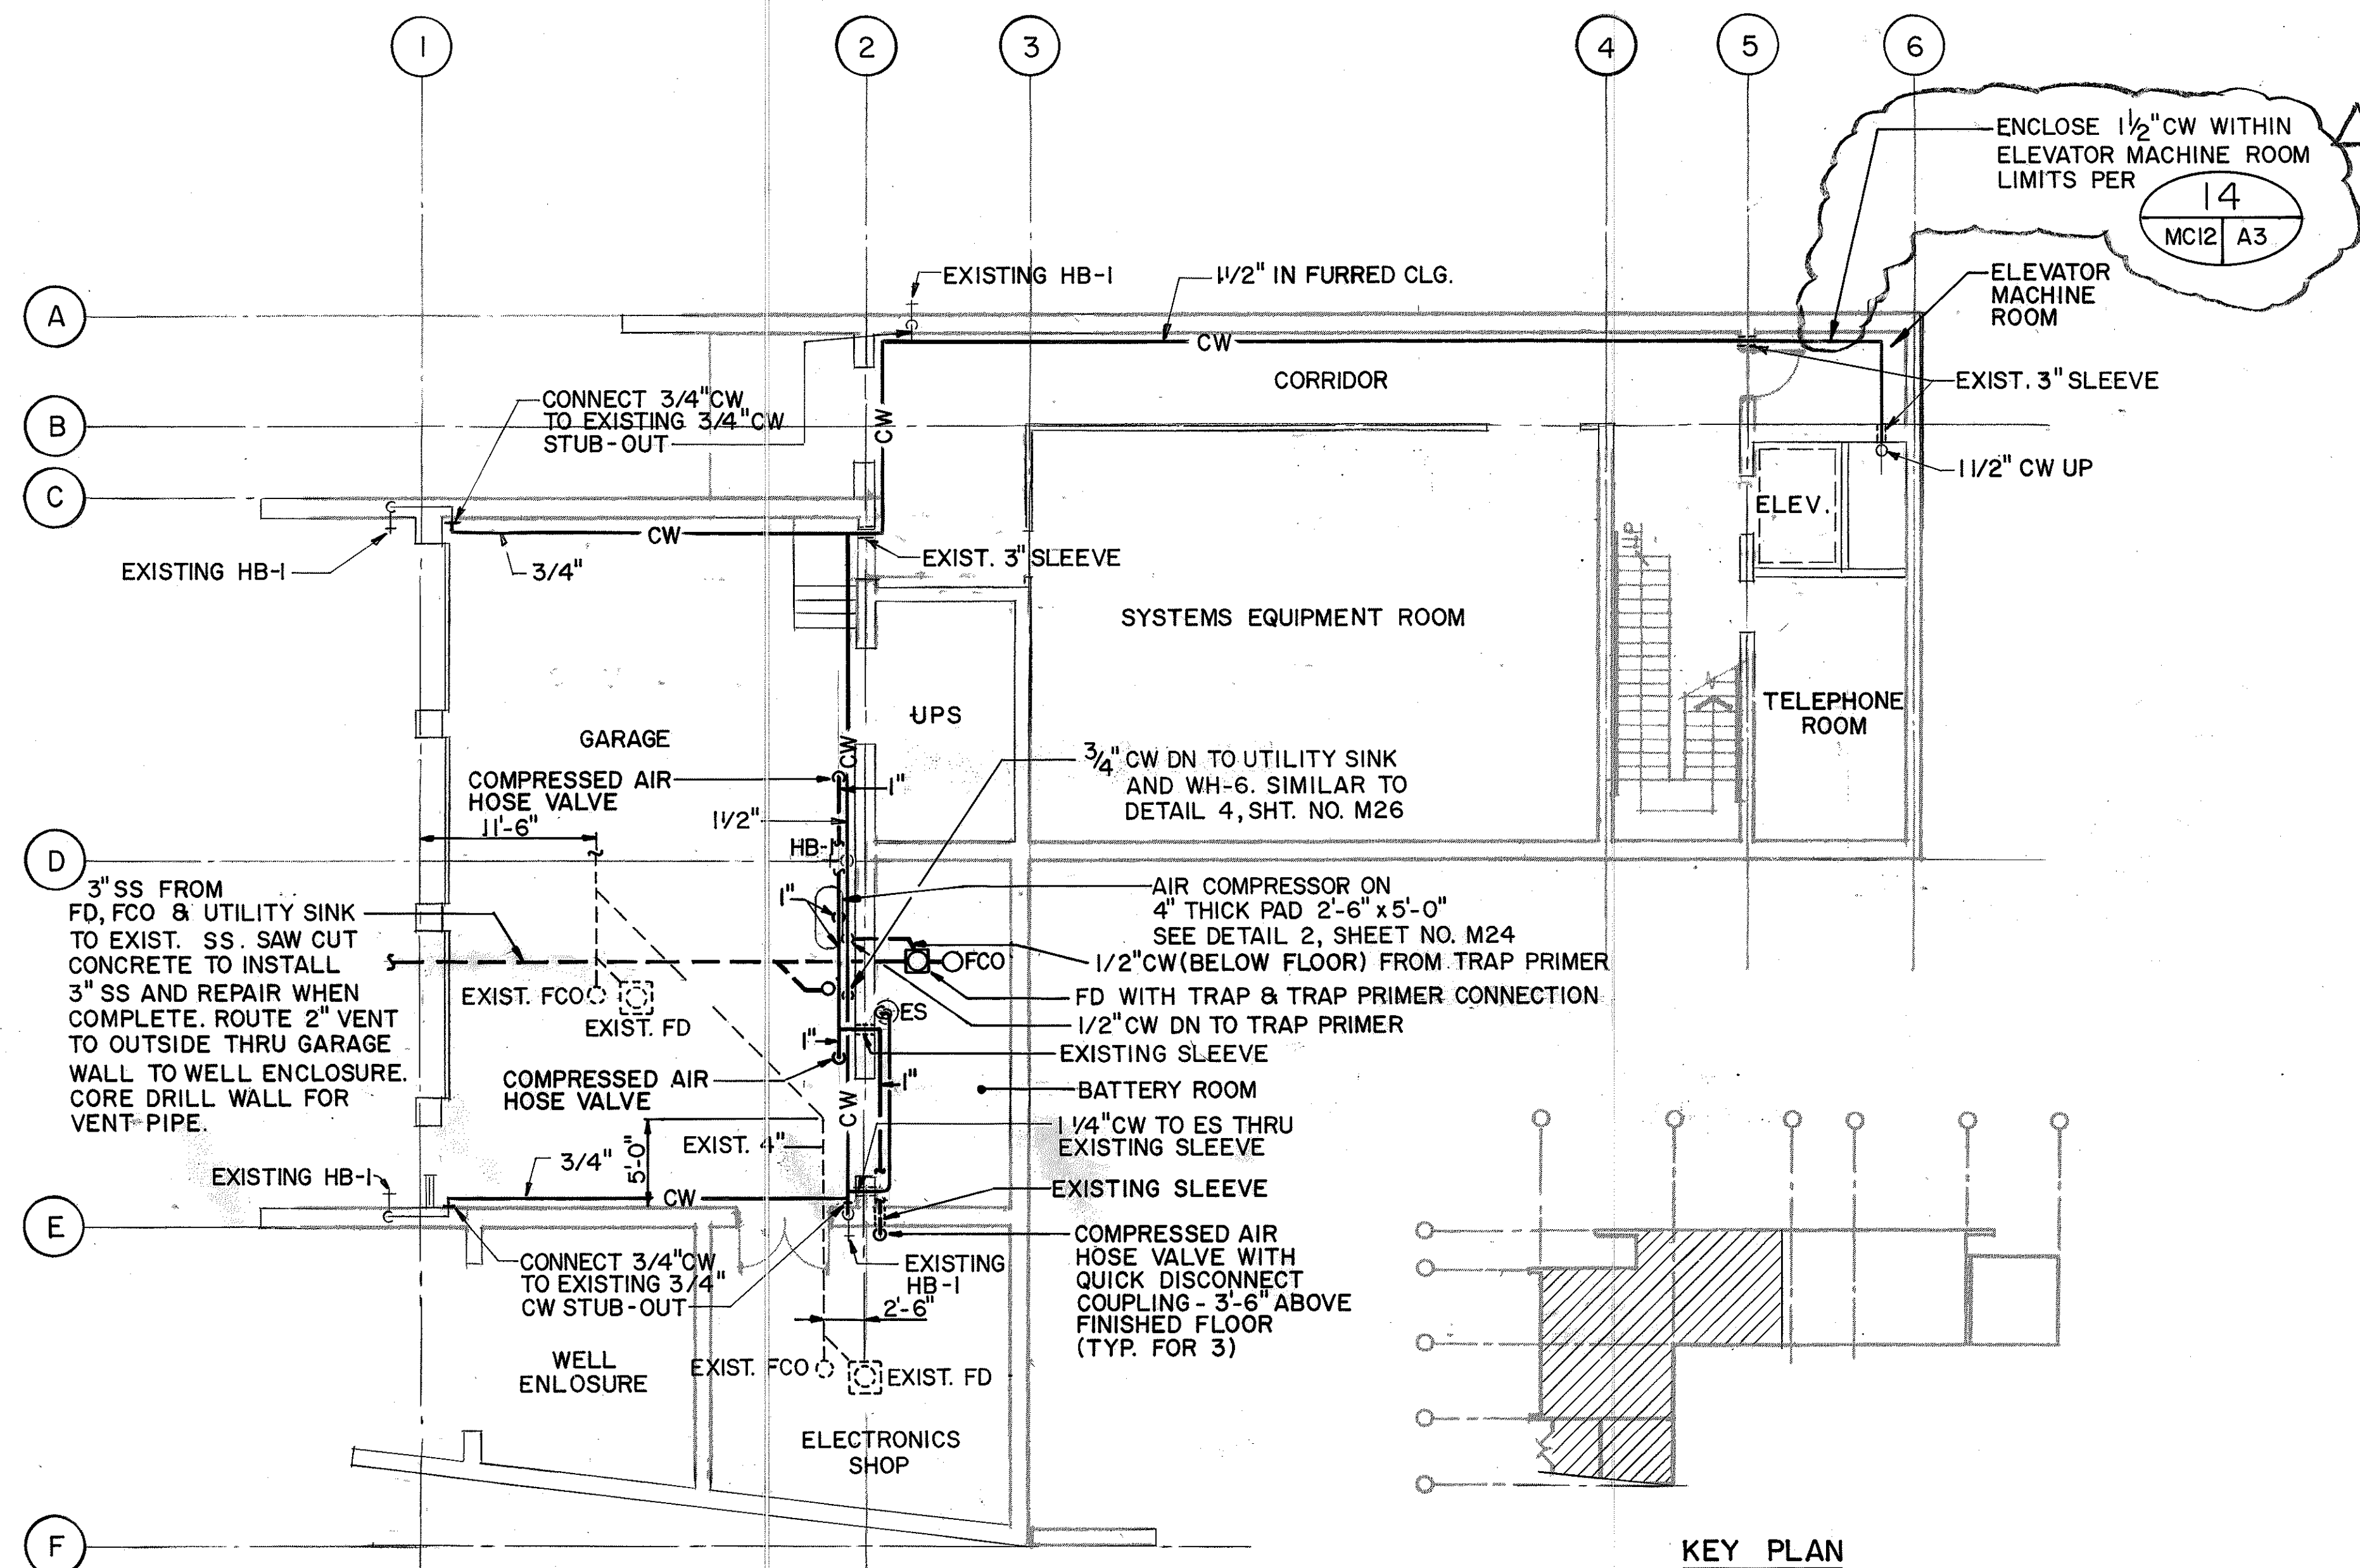

LEVEL I PLAN

KEY PLAN


FOR DETAIL AS-BUILT INFORMATION
REFER TO CONSTRUCTION SUBMITTALS

ORIGINAL PLAN	DATE
DESIGNED BY	12/28/93
DRAWN BY	12/14/93
CHECKED BY	06/01/90
NOTED BY	
NO.	

GRAPHIC SCALE

8' 0' 8' 16'

1/8" = 1'-0"

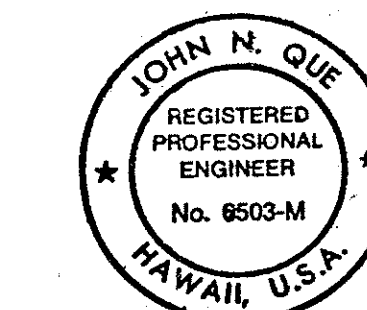


THIS WORK WAS PREPARED BY ME
OR UNDER MY SUPERVISION



John N. Que

DATE	REVISION
9/19/94	REV. PER DCN 66-052
10/21/94	REV. PER DCN 66-051
7/22/92	ADDENDUM 1-RELOCATED ES
STATE OF HAWAII DEPARTMENT OF TRANSPORTATION HIGHWAYS DIVISION	
PLUMBING - LEVEL I PLAN CONTROL BUILDING INTERSTATE ROUTE H-3 F.A.I. PROJ. NO. I-H3-I(66)	
SCALE: 1/8" = 1'-0"	DATE: APR 1992
SHEET NO. MC12 OF 19 SHEETS	



FED. ROAD DIST. NO.	STATE	FED. AID PROJ. NO.	FISCAL YEAR	SHEET NO.	TOTAL SHEETS
HAWAII	HAW.	I-H3-1(66)	1992	67	440

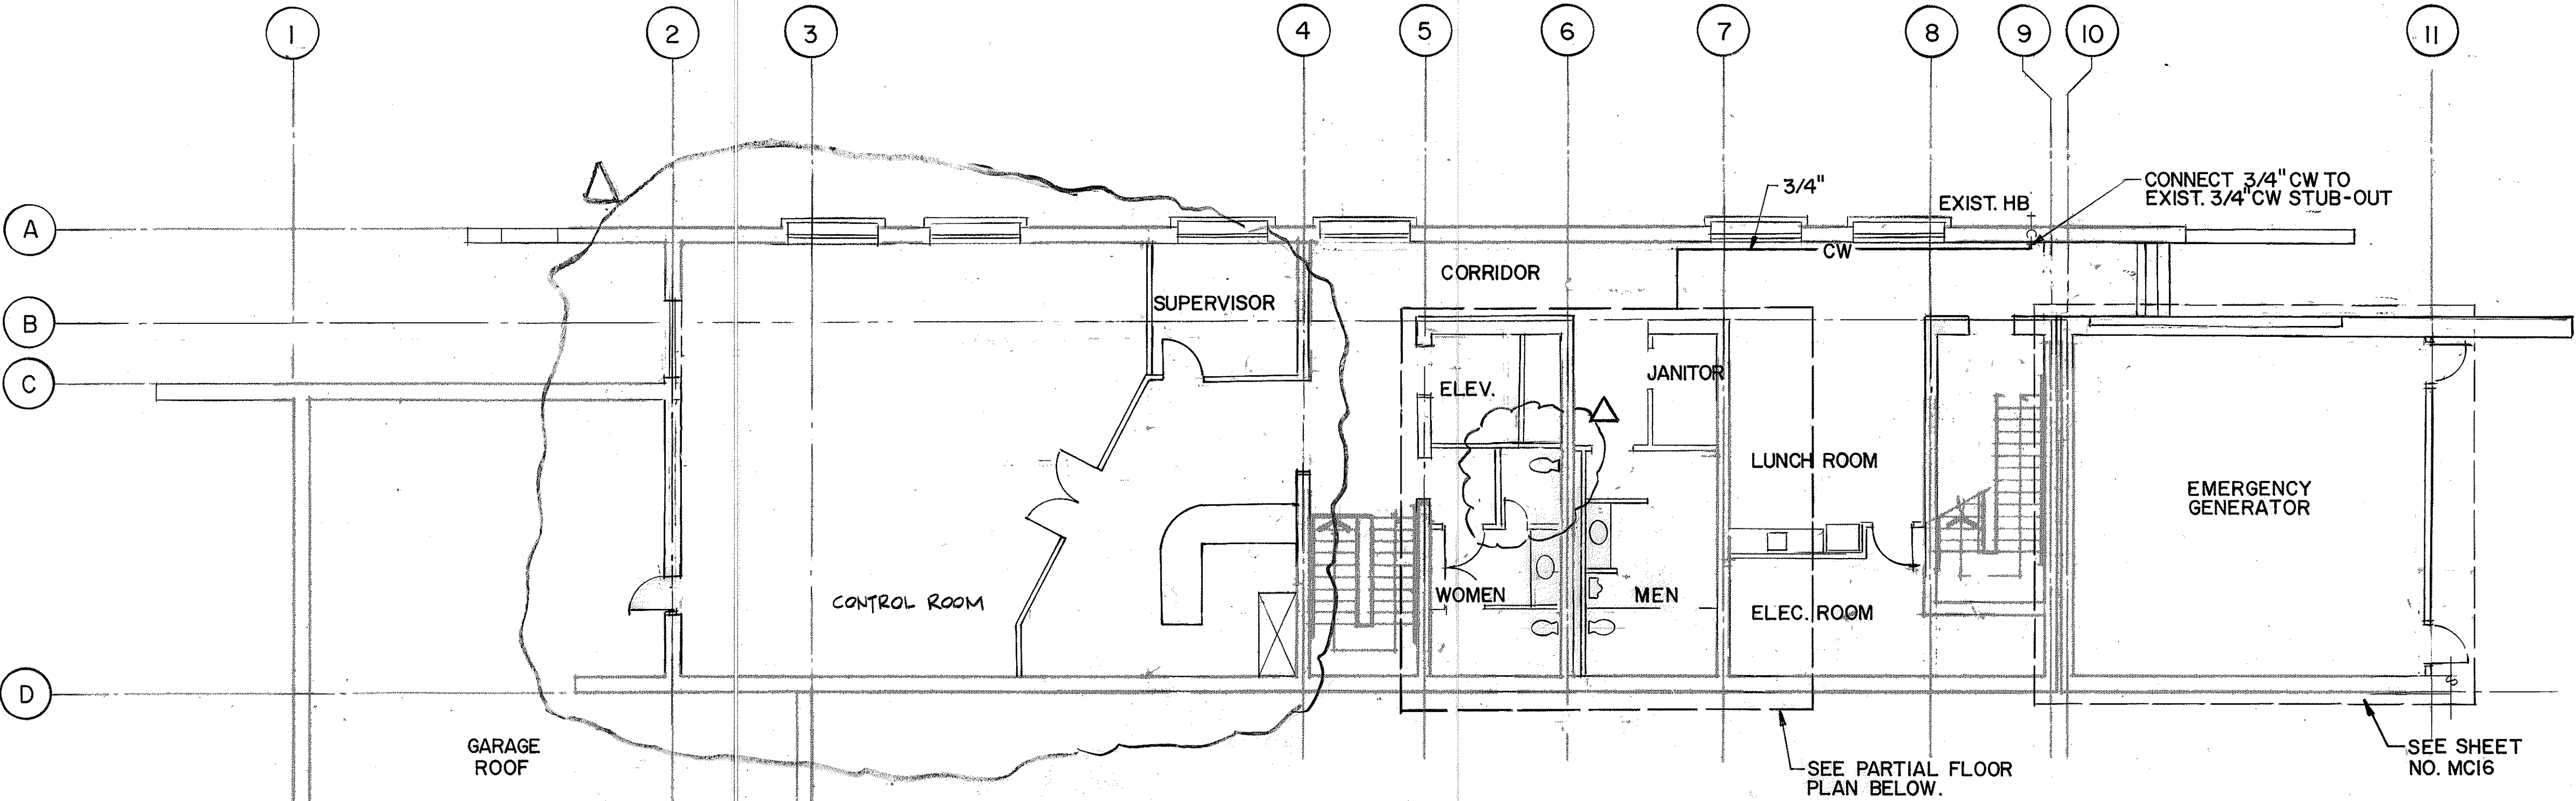

LEVEL 2 PLAN
SCALE: 1/8"=1'-0"

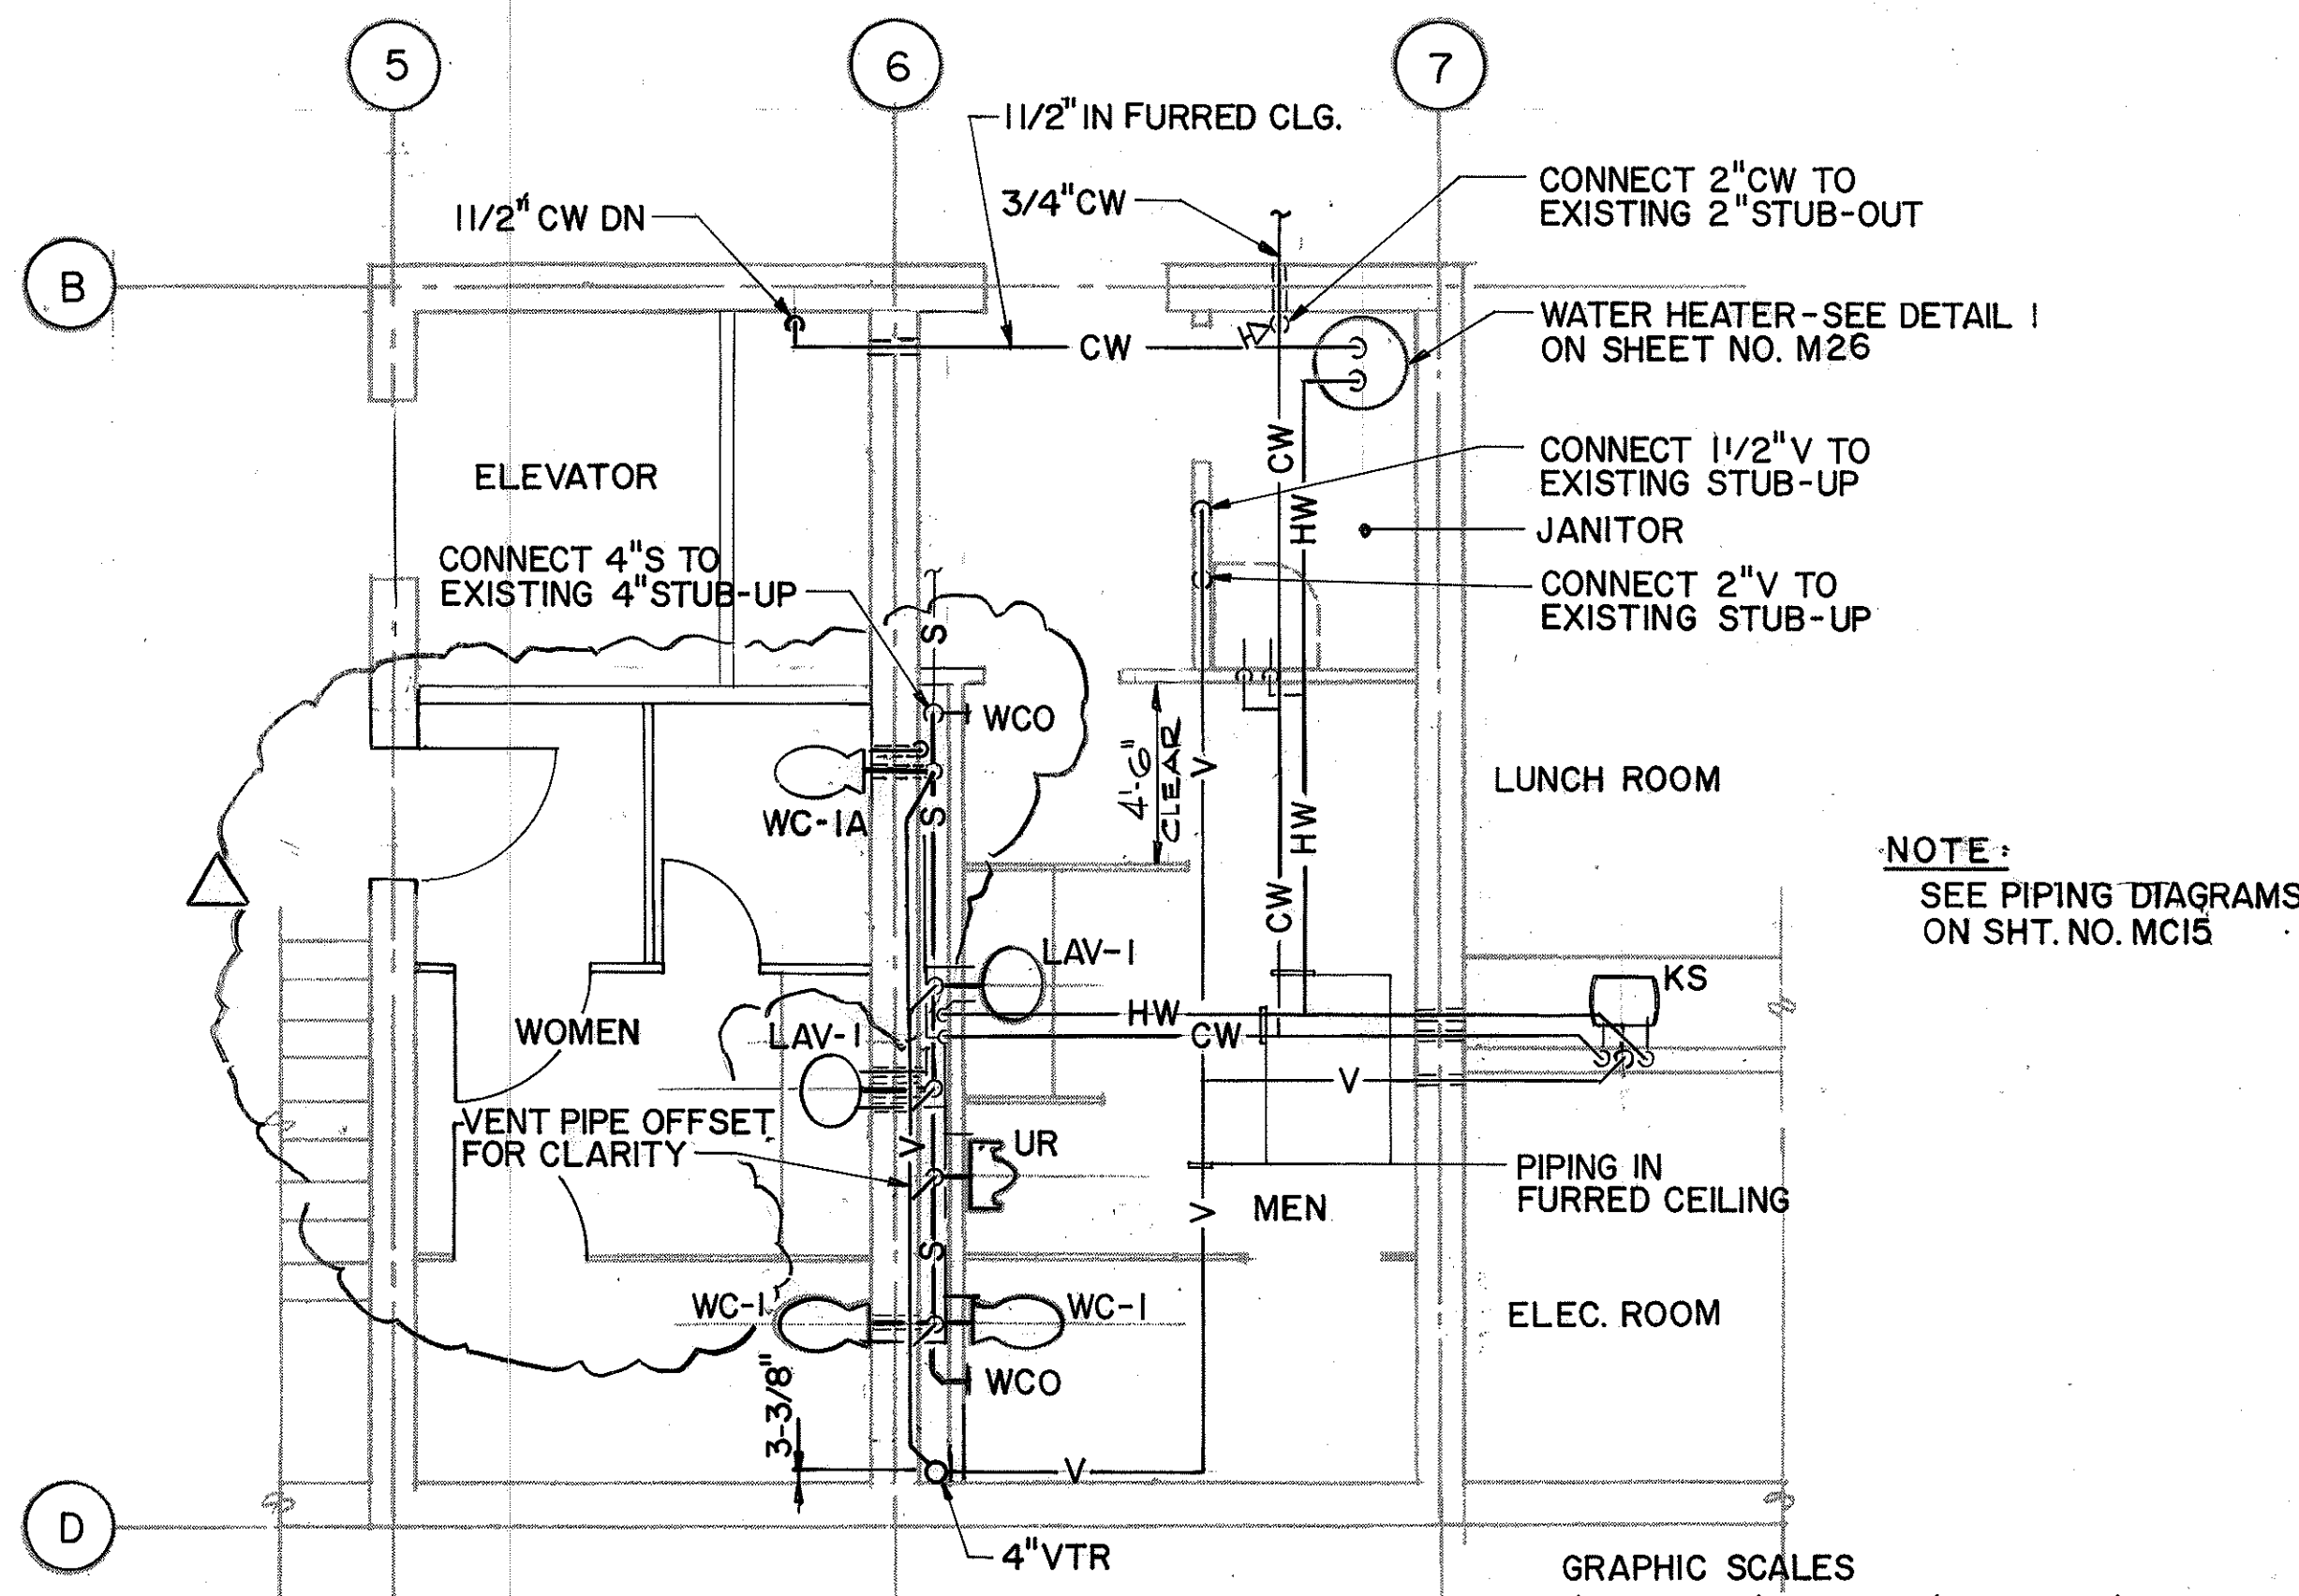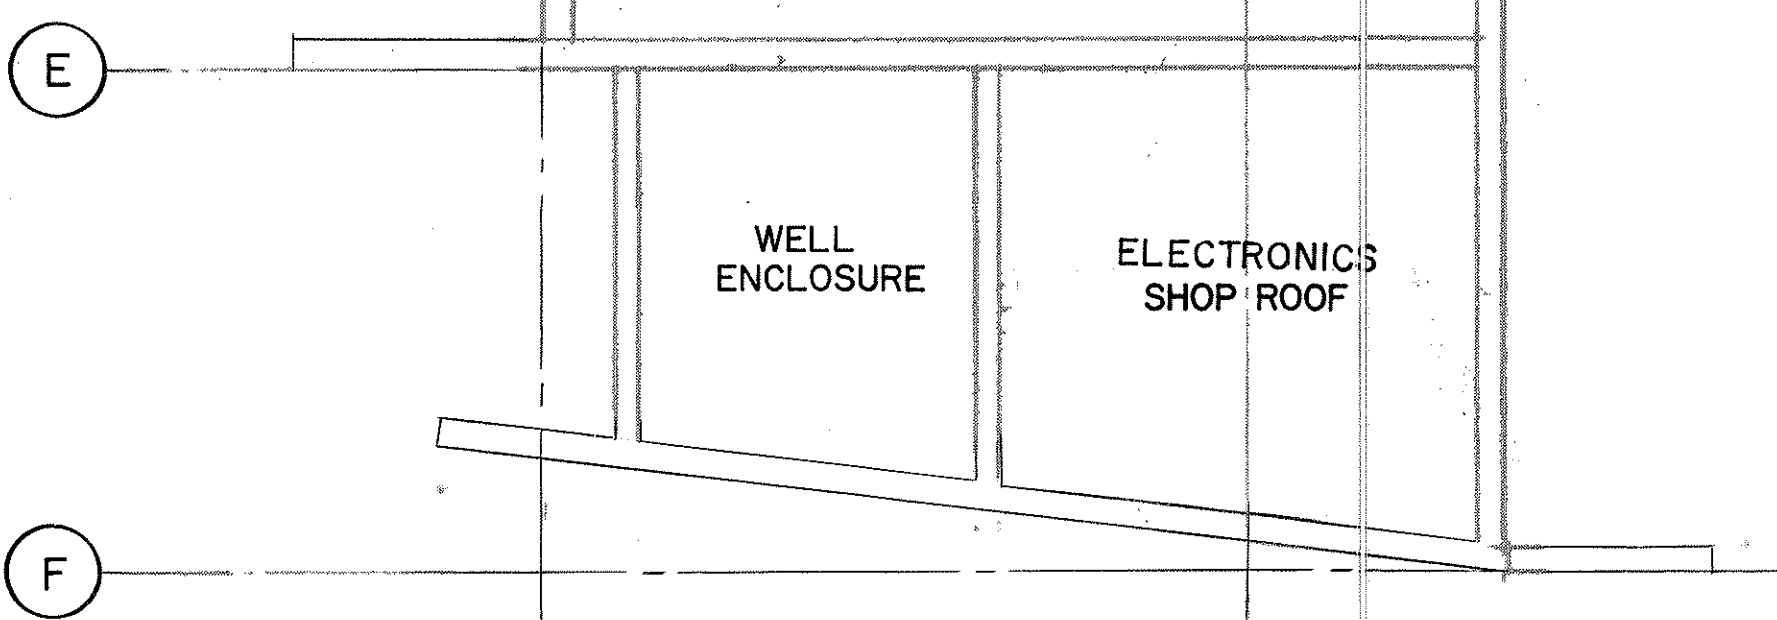

PARTIAL FLOOR PLAN
SCALE: 1/4"=1'-0"

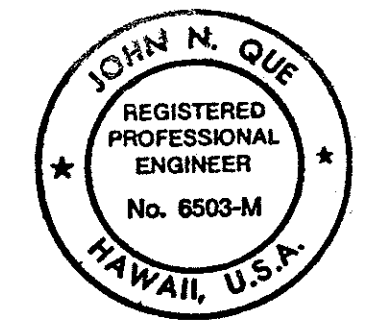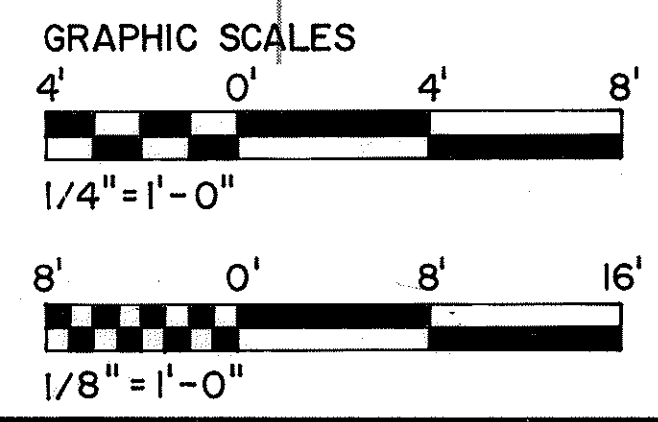

THIS WORK WAS PREPARED BY ME OR UNDER MY SUPERVISION

John N. Que

NOTE:
SEE PIPING DIAGRAMS
ON SHT. NO. MC15

12/9/94	REV. PER DCN 66-054A
1/19/94	REV. TO REFLECT NEW CONTROL CENTER LAYOUT PER DCN 66-030
2/2/93	REVISED WALL LOCATION BETWEEN MEN'S TOILET AND J.C. IN ACCORDANCE WITH ADA REGULATIONS PER DCN 66-001
DATE	REVISION

STATE OF HAWAII
DEPARTMENT OF TRANSPORTATION
HIGHWAYS DIVISION

**PLUMBING -
LEVEL 2 PLANS**


CONTROL BUILDING

INTERSTATE ROUTE H-3
F.A.I. PROJ. NO. I-H3-1(66)


SCALE: AS NOTED
DATE: APR 1992
SHEET NO. MC13 OF 19 SHEETS

ORIGINAL PLAN	DATE
NO.	12/1/89
DESIGNED BY	BY
CHECKED BY	BY
DATE	11/16/89
DATE	05/01/90


FED. ROAD DIST. NO.	STATE	FED. AID PROJ. NO.	FISCAL YEAR	SHEET NO.	TOTAL SHEETS
HAWAII	HAW.	I-H3-1(66)	1992	68	440

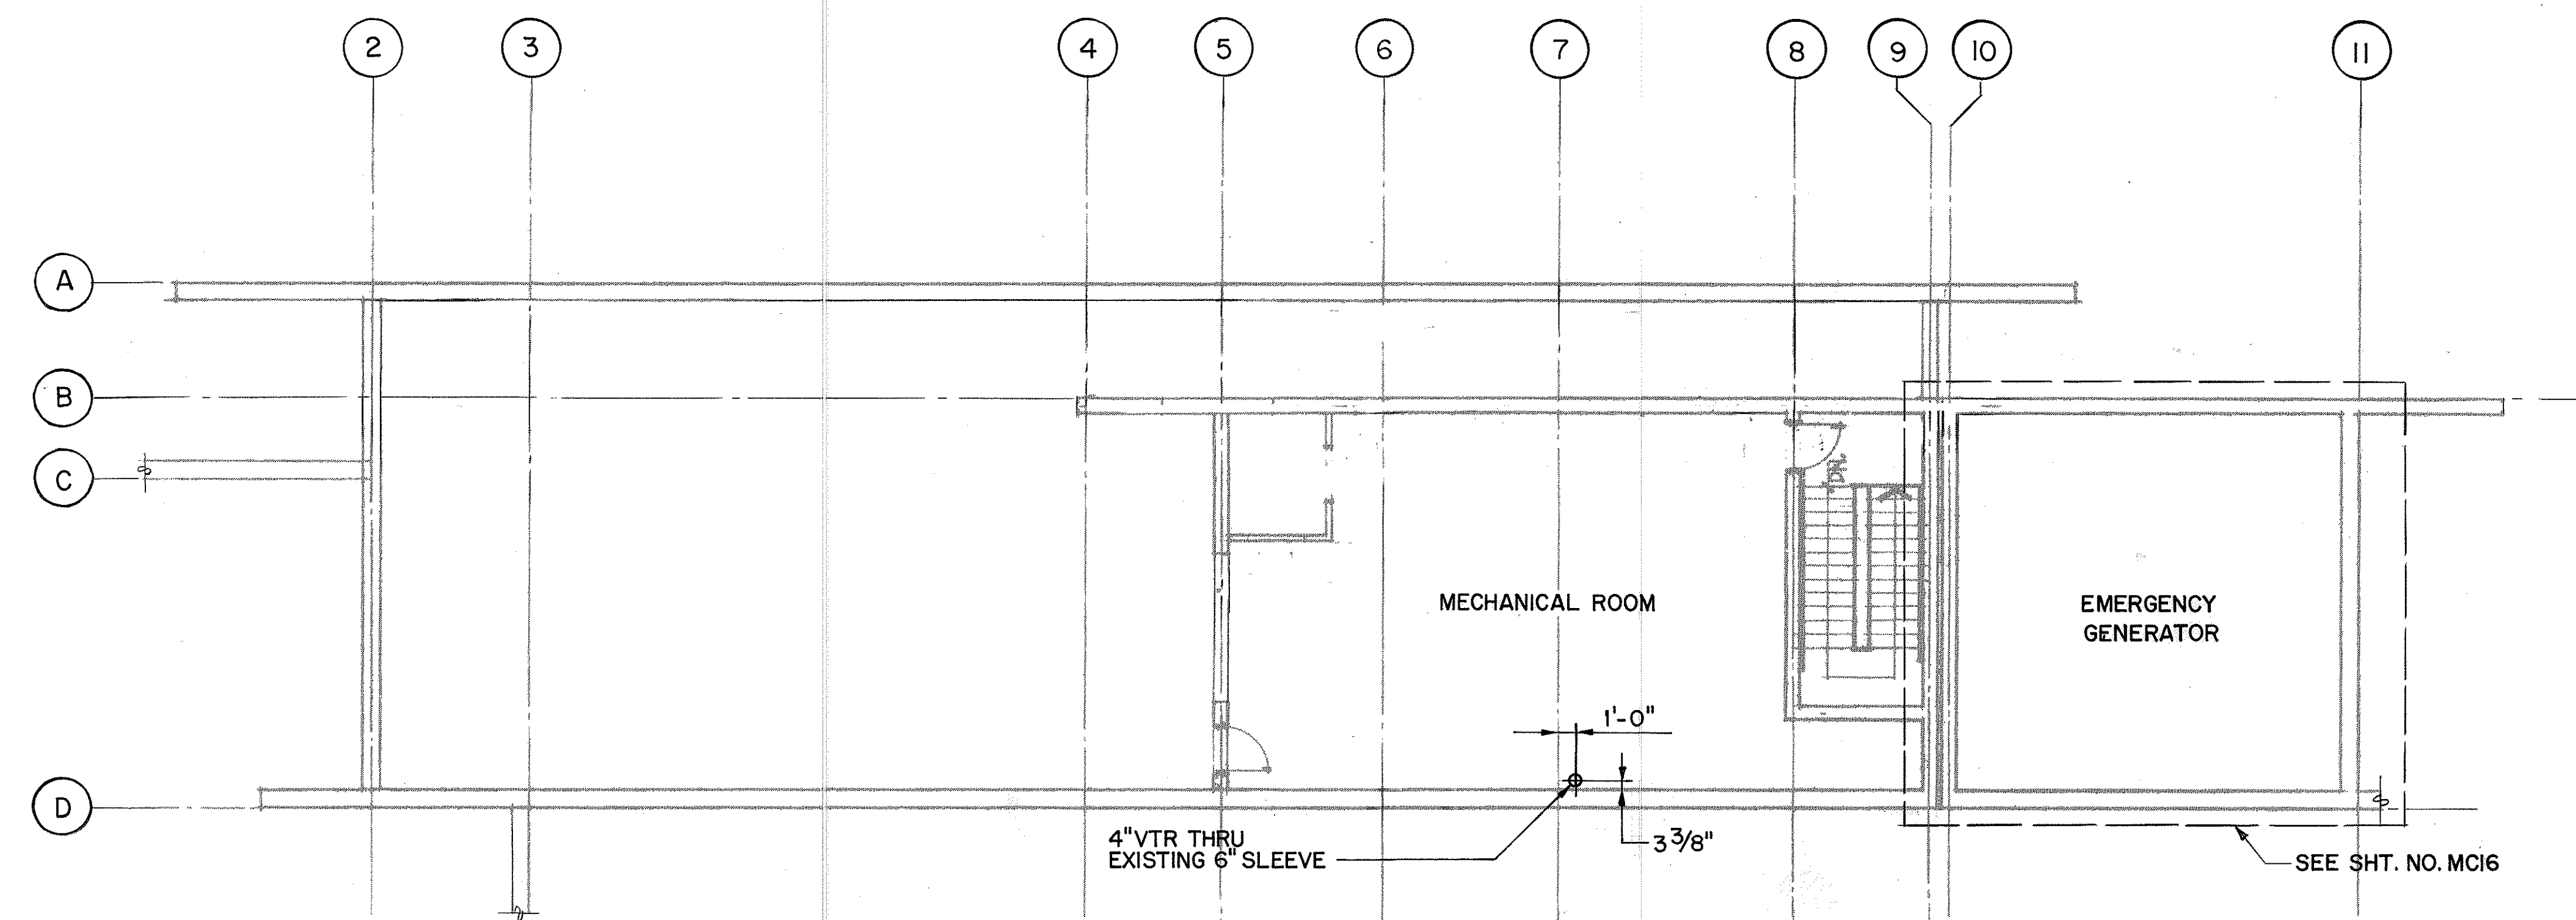


LEVEL 3 PLAN

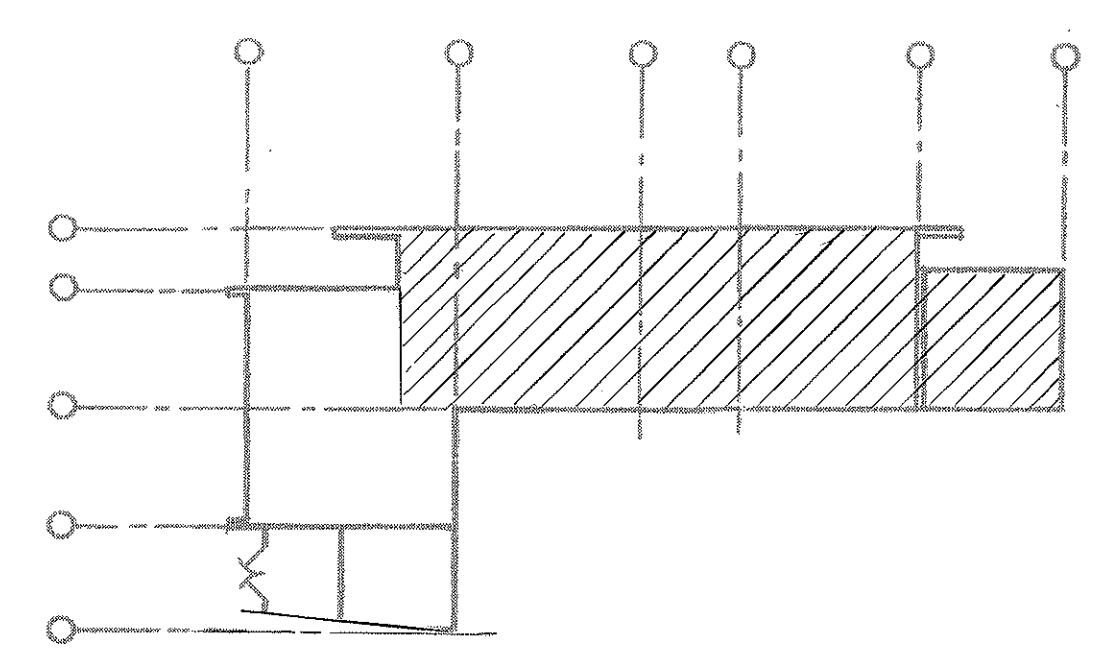



KEY PLAN

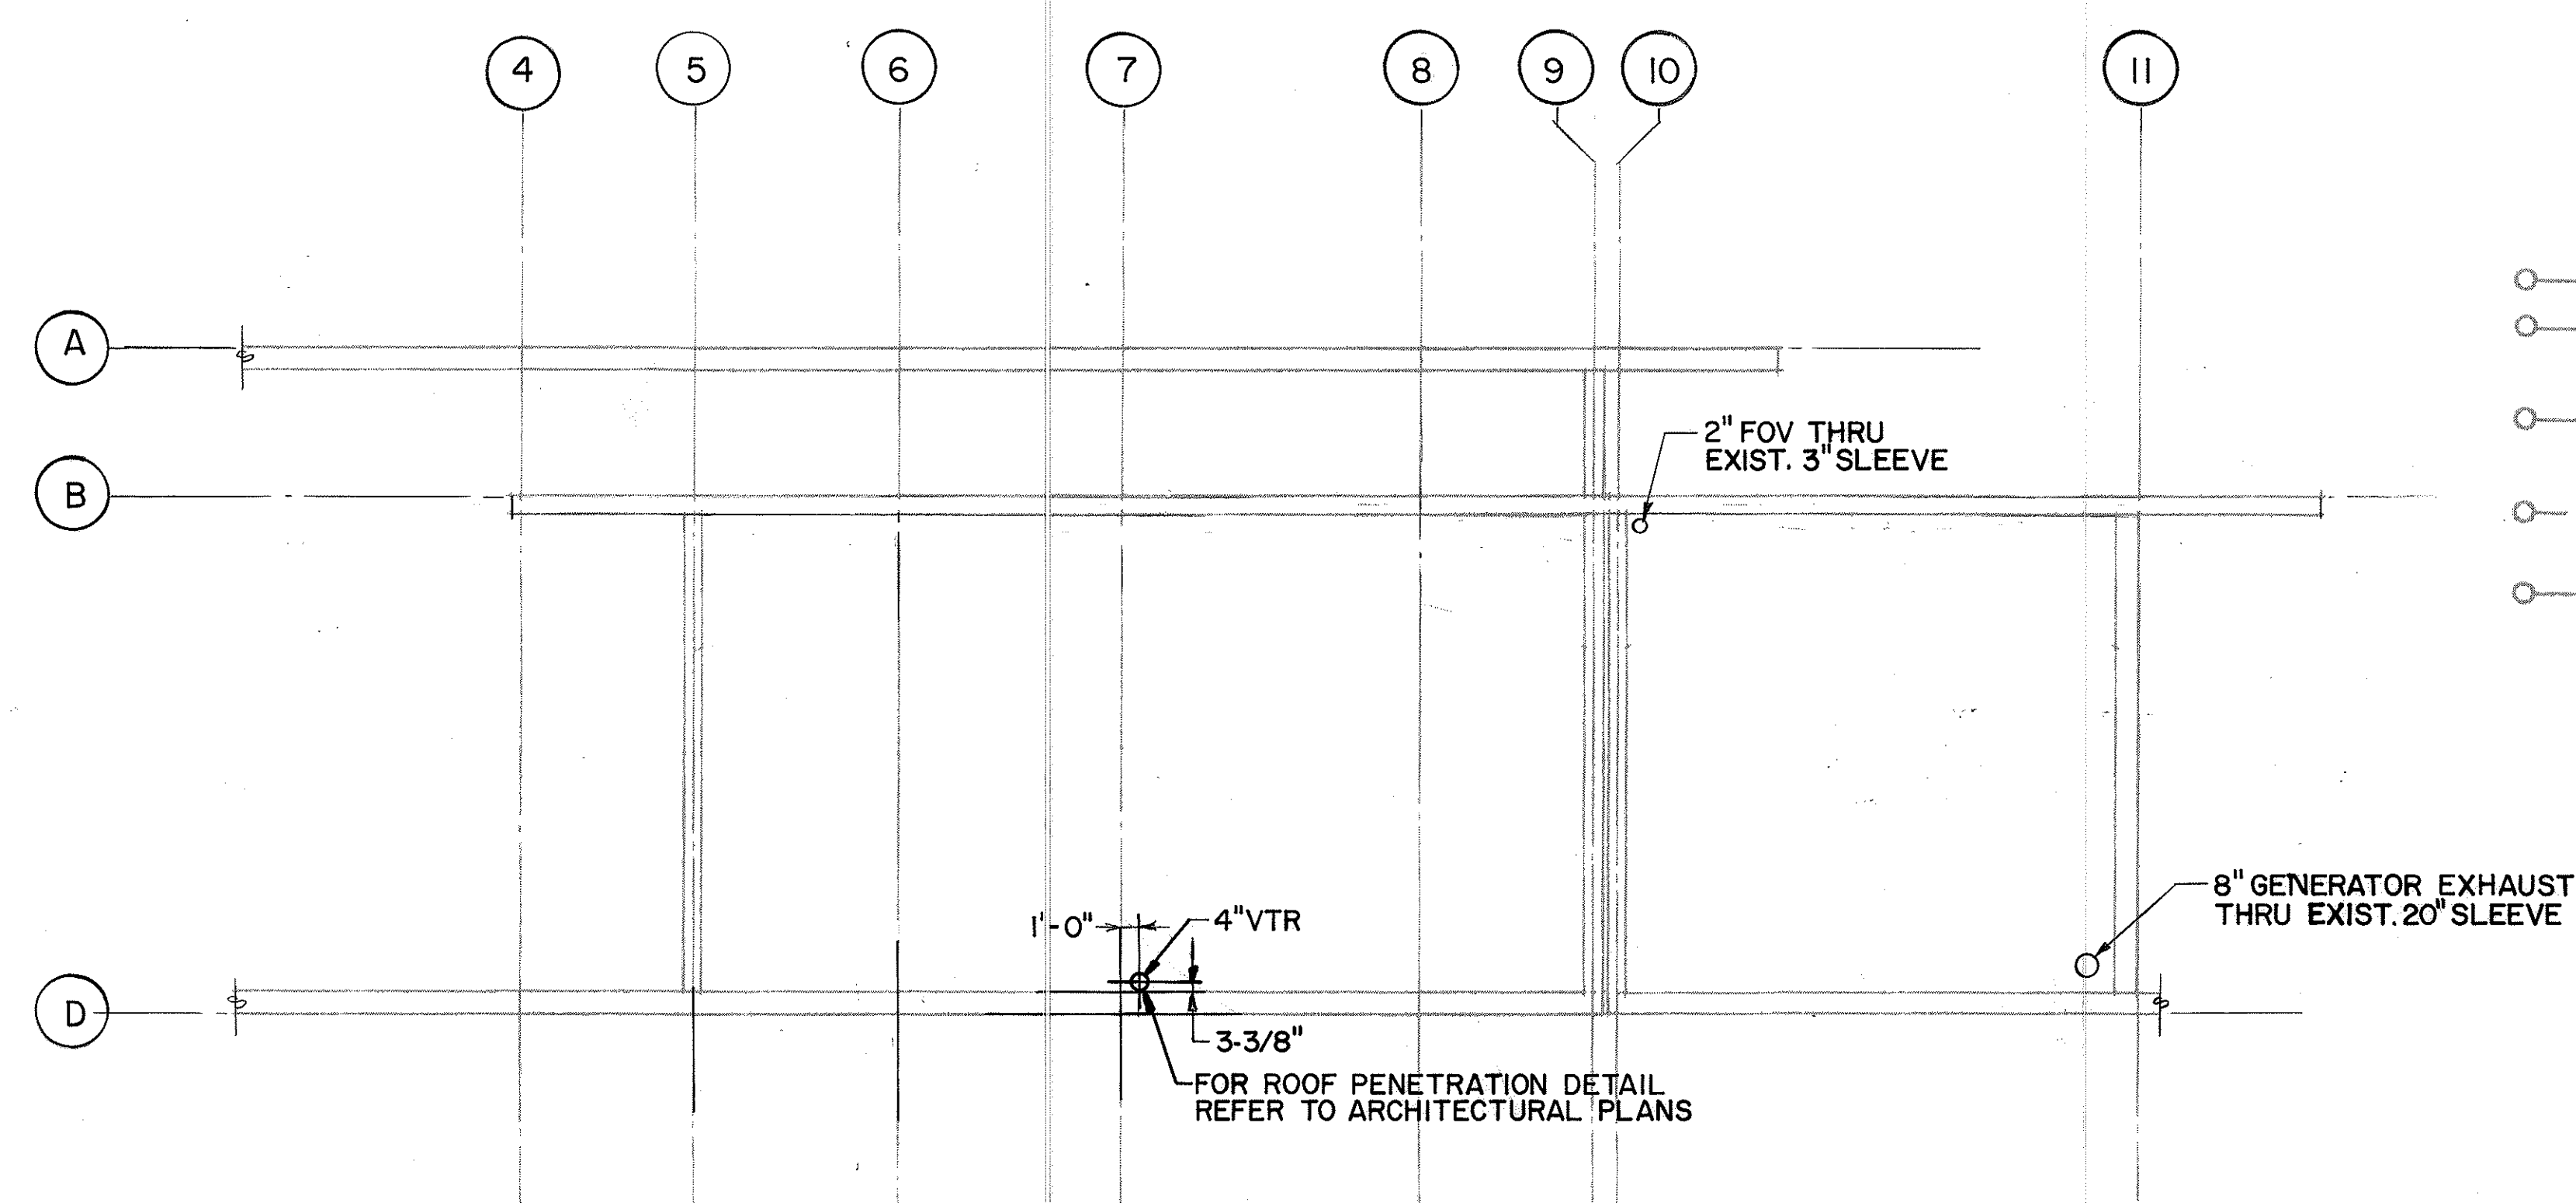

ROOF LEVEL PLAN

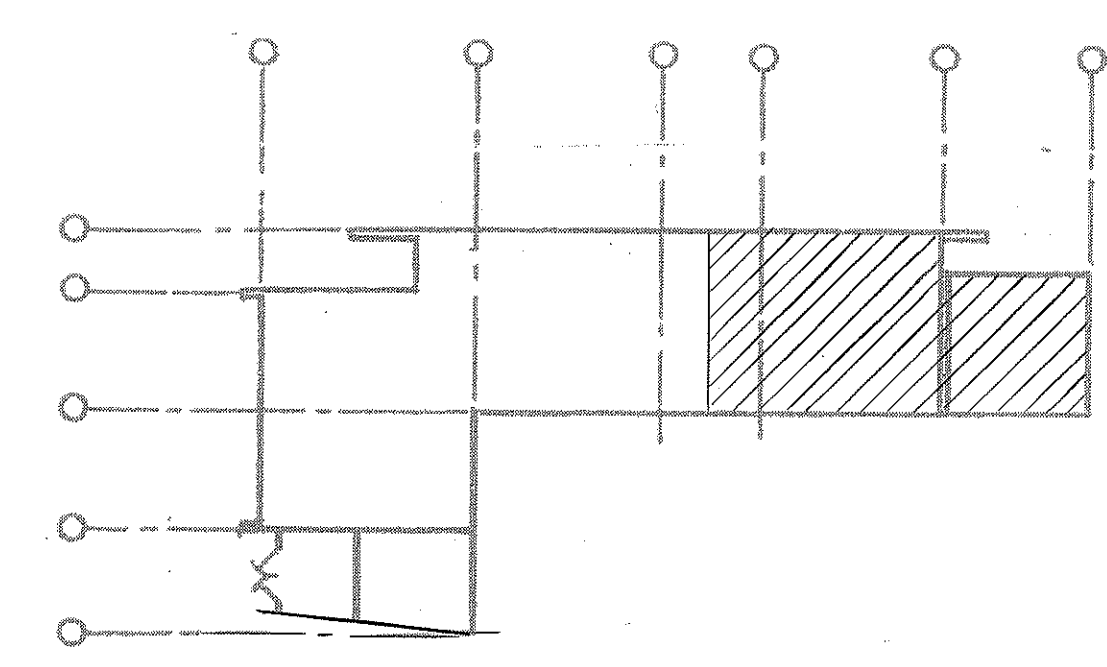

KEY PLAN

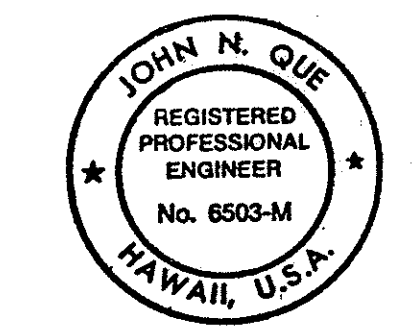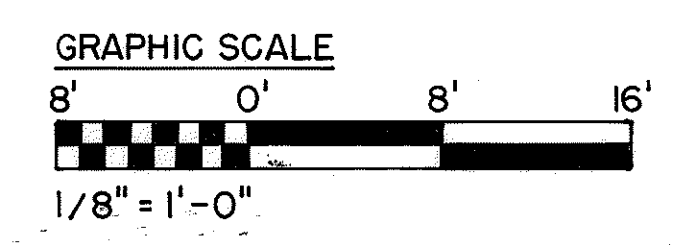


THIS WORK WAS PREPARED BY ME
OR UNDER MY SUPERVISION

John N. Que


STATE OF HAWAII
DEPARTMENT OF TRANSPORTATION
HIGHWAYS DIVISION
**PLUMBING - LEVEL 3 &
ROOF PLANS**
CONTROL BUILDING
INTERSTATE ROUTE H-3
F.A.I. PROJ. NO. I-H3-1 (66)
SCALE: 1/8" = 1'-0" DATE: APR 1992.
SHEET NO. MC14 OF 19 SHEETS

SURVEY PLOTTED BY	DATE
DRAWN BY	12/26/89
CHECKED BY	12/21/89
NOTED BY	06/01/90
ORIGINAL PLAN	
NOTE BOOK	
No.	

FED. ROAD DIST. NO.	STATE	FED. AID PROJ. NO.	FISCAL YEAR	SHEET NO.	TOTAL SHEETS
HAWAII	HAW.	I-H3-1(66)	1992	69	440

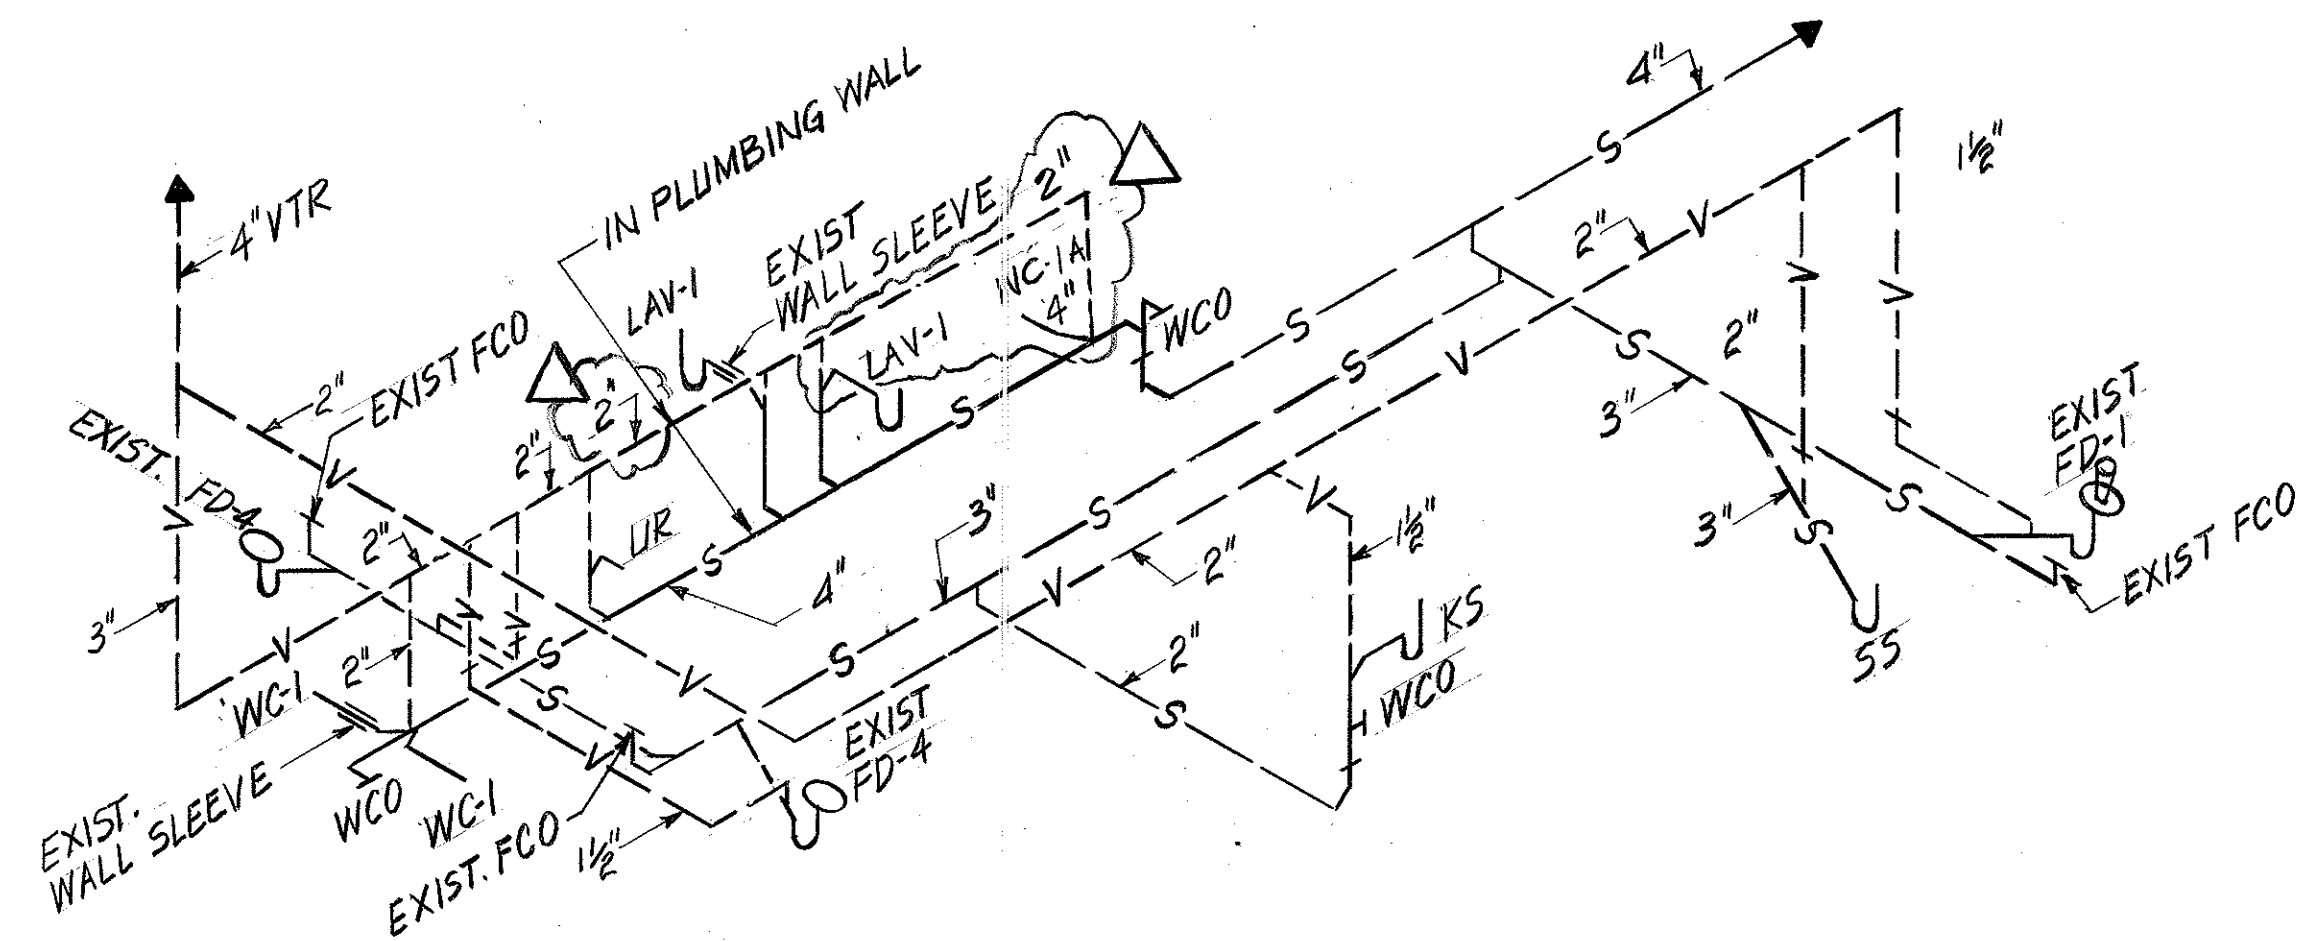


SANITARY PIPING DIAGRAM

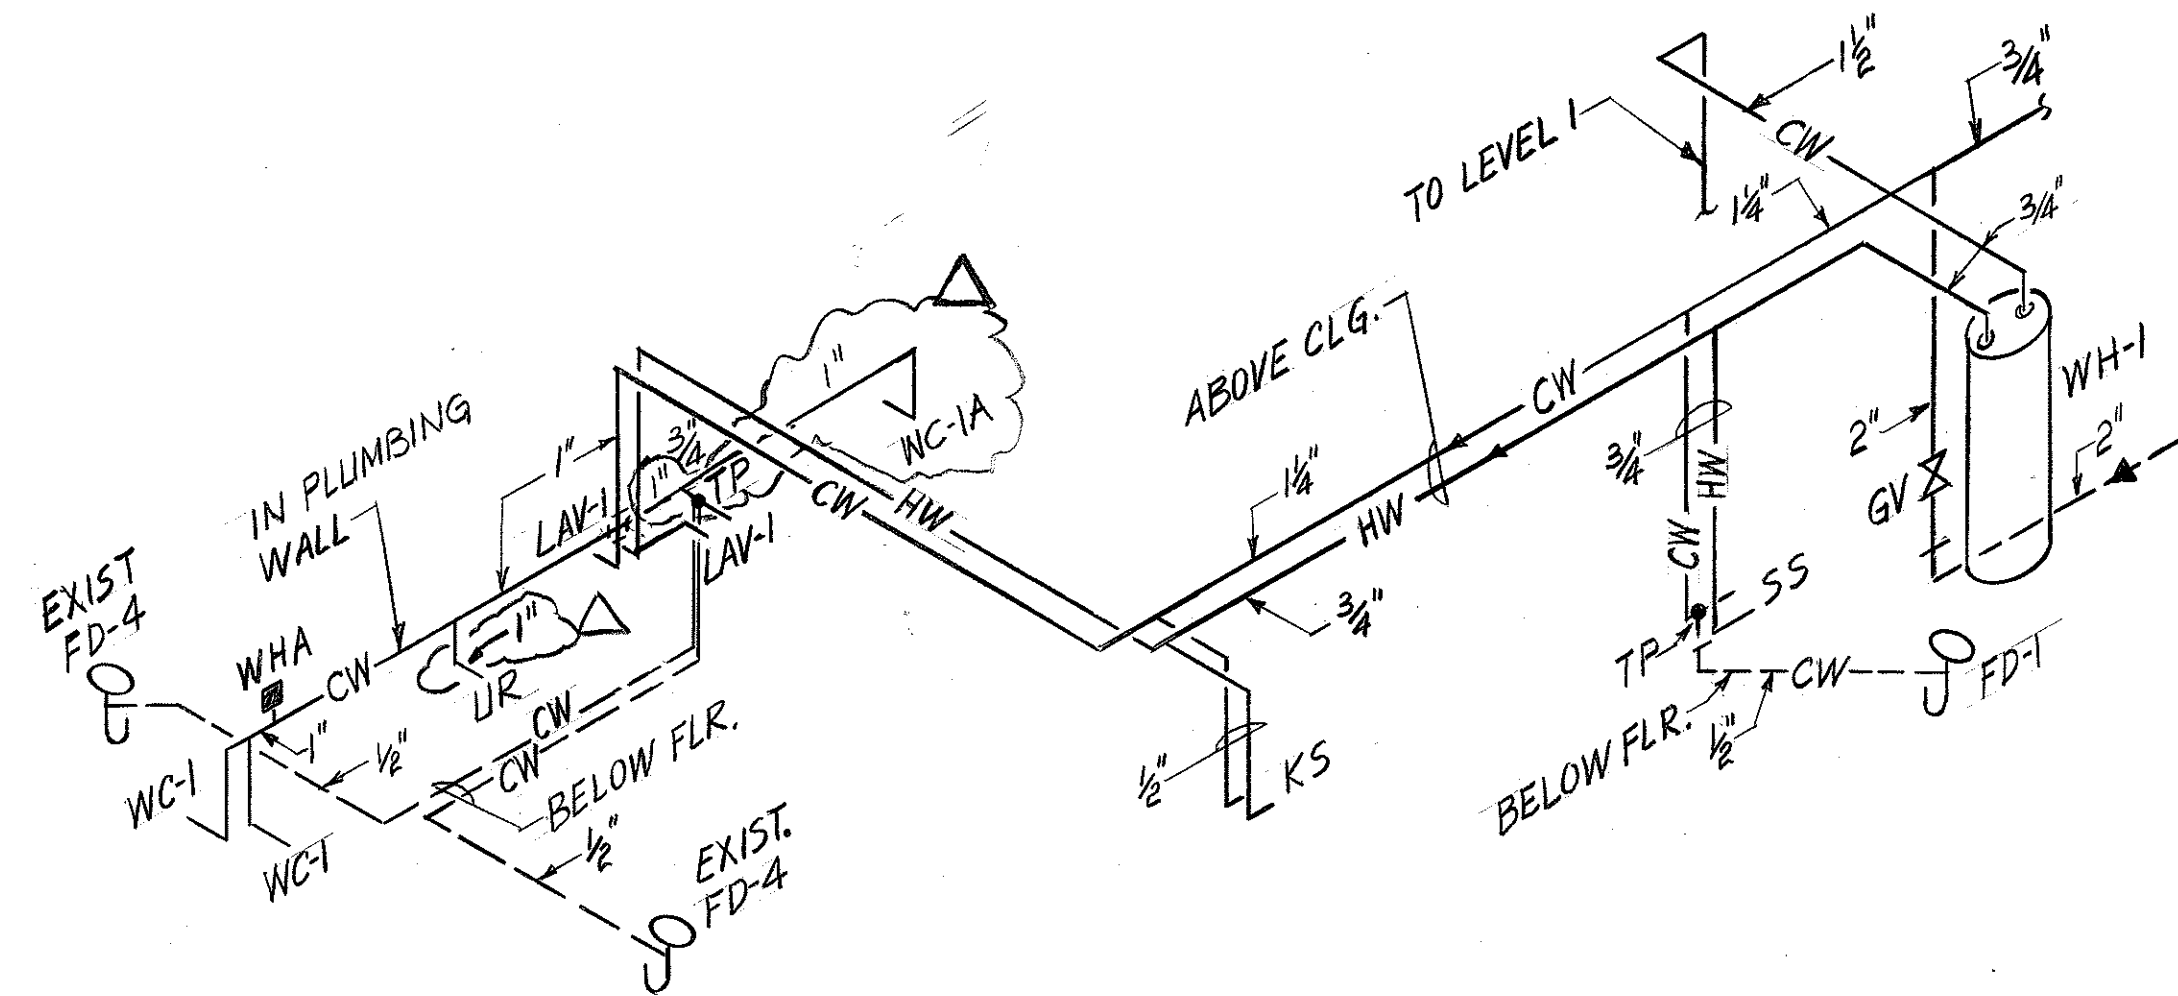

HOT & COLD WATER PIPING DIAGRAM

ORIGINAL PLAN	SURVEY PLOTTED BY P. L. LAQUE	DATE 01/24/90
NOTE BOOK	DRAWN BY P. L. LAQUE	12/13/89
No.	CHECKED BY J. N. QUE	06/01/90

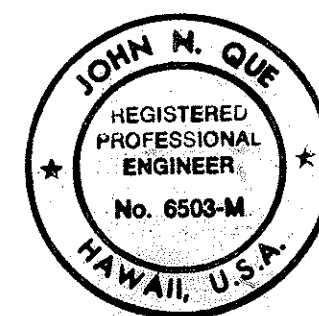


THIS WORK WAS PREPARED BY ME
OR UNDER MY SUPERVISION

John M. Que



2/20/95	REV. PER DCN 66-054A
DATE	REVISION
STATE OF HAWAII DEPARTMENT OF TRANSPORTATION HIGHWAYS DIVISION PLUMBING RISER DIAGRAMS CONTROL BUILDING INTERSTATE ROUTE H-3 F.A.I. PROJ. NO. I-H3-1(66)	
SCALE: NONE	DATE: APR. 1992
SHEET NO. MC15 OF 19 SHEETS	

FED. ROAD DIST. NO.	STATE	FED. AID PROJ. NO.	FISCAL YEAR	SHEET NO.	TOTAL SHEETS
HAWAII	HAW.	I - H3 - I(66)	1992	70	440

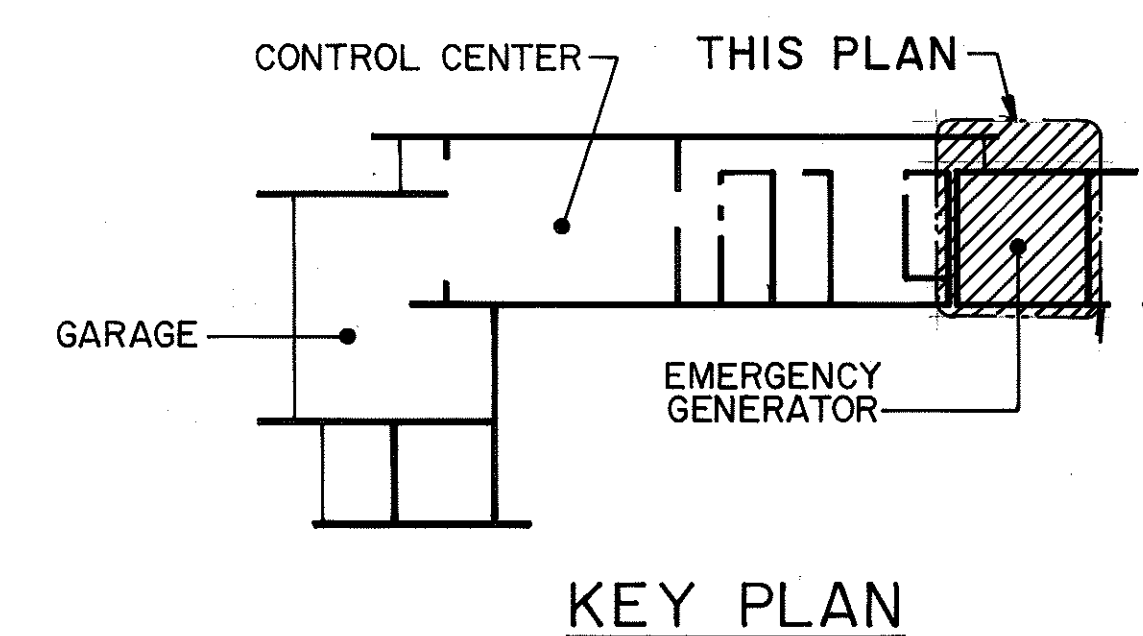

NOTES:

I. FOS = FUEL OIL SUPPLY
FOR = FUEL OIL RETURN
FOV = FUEL OIL VENT

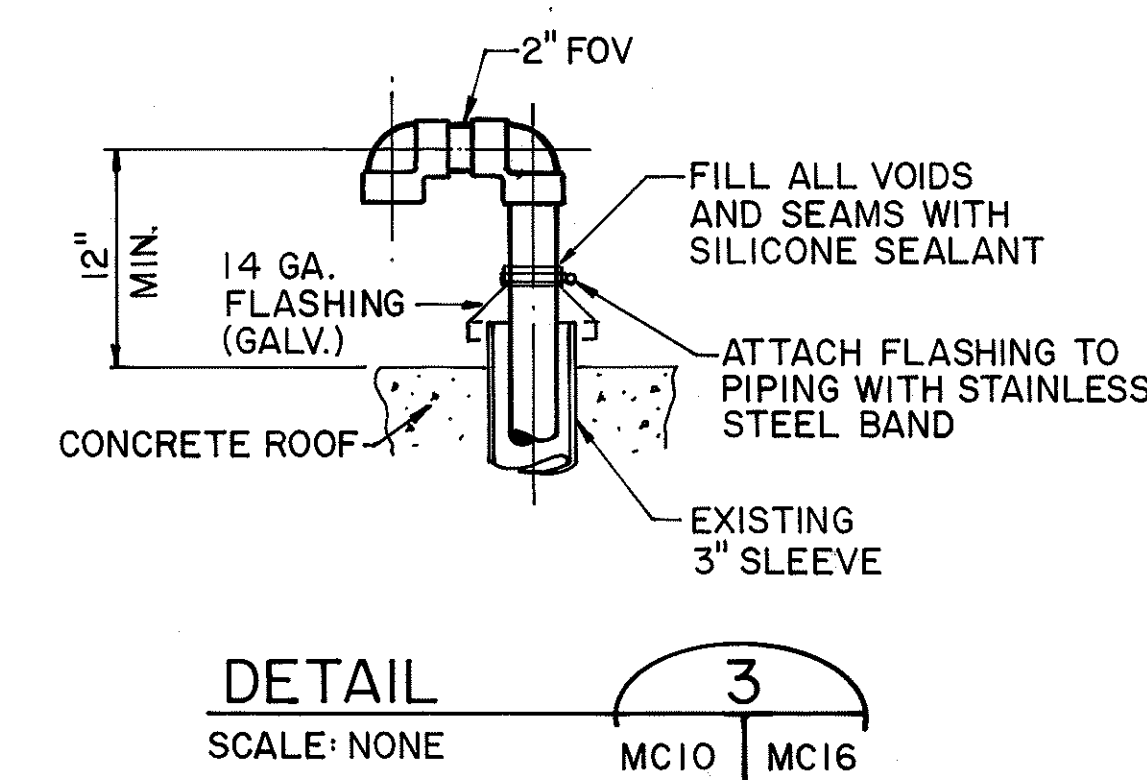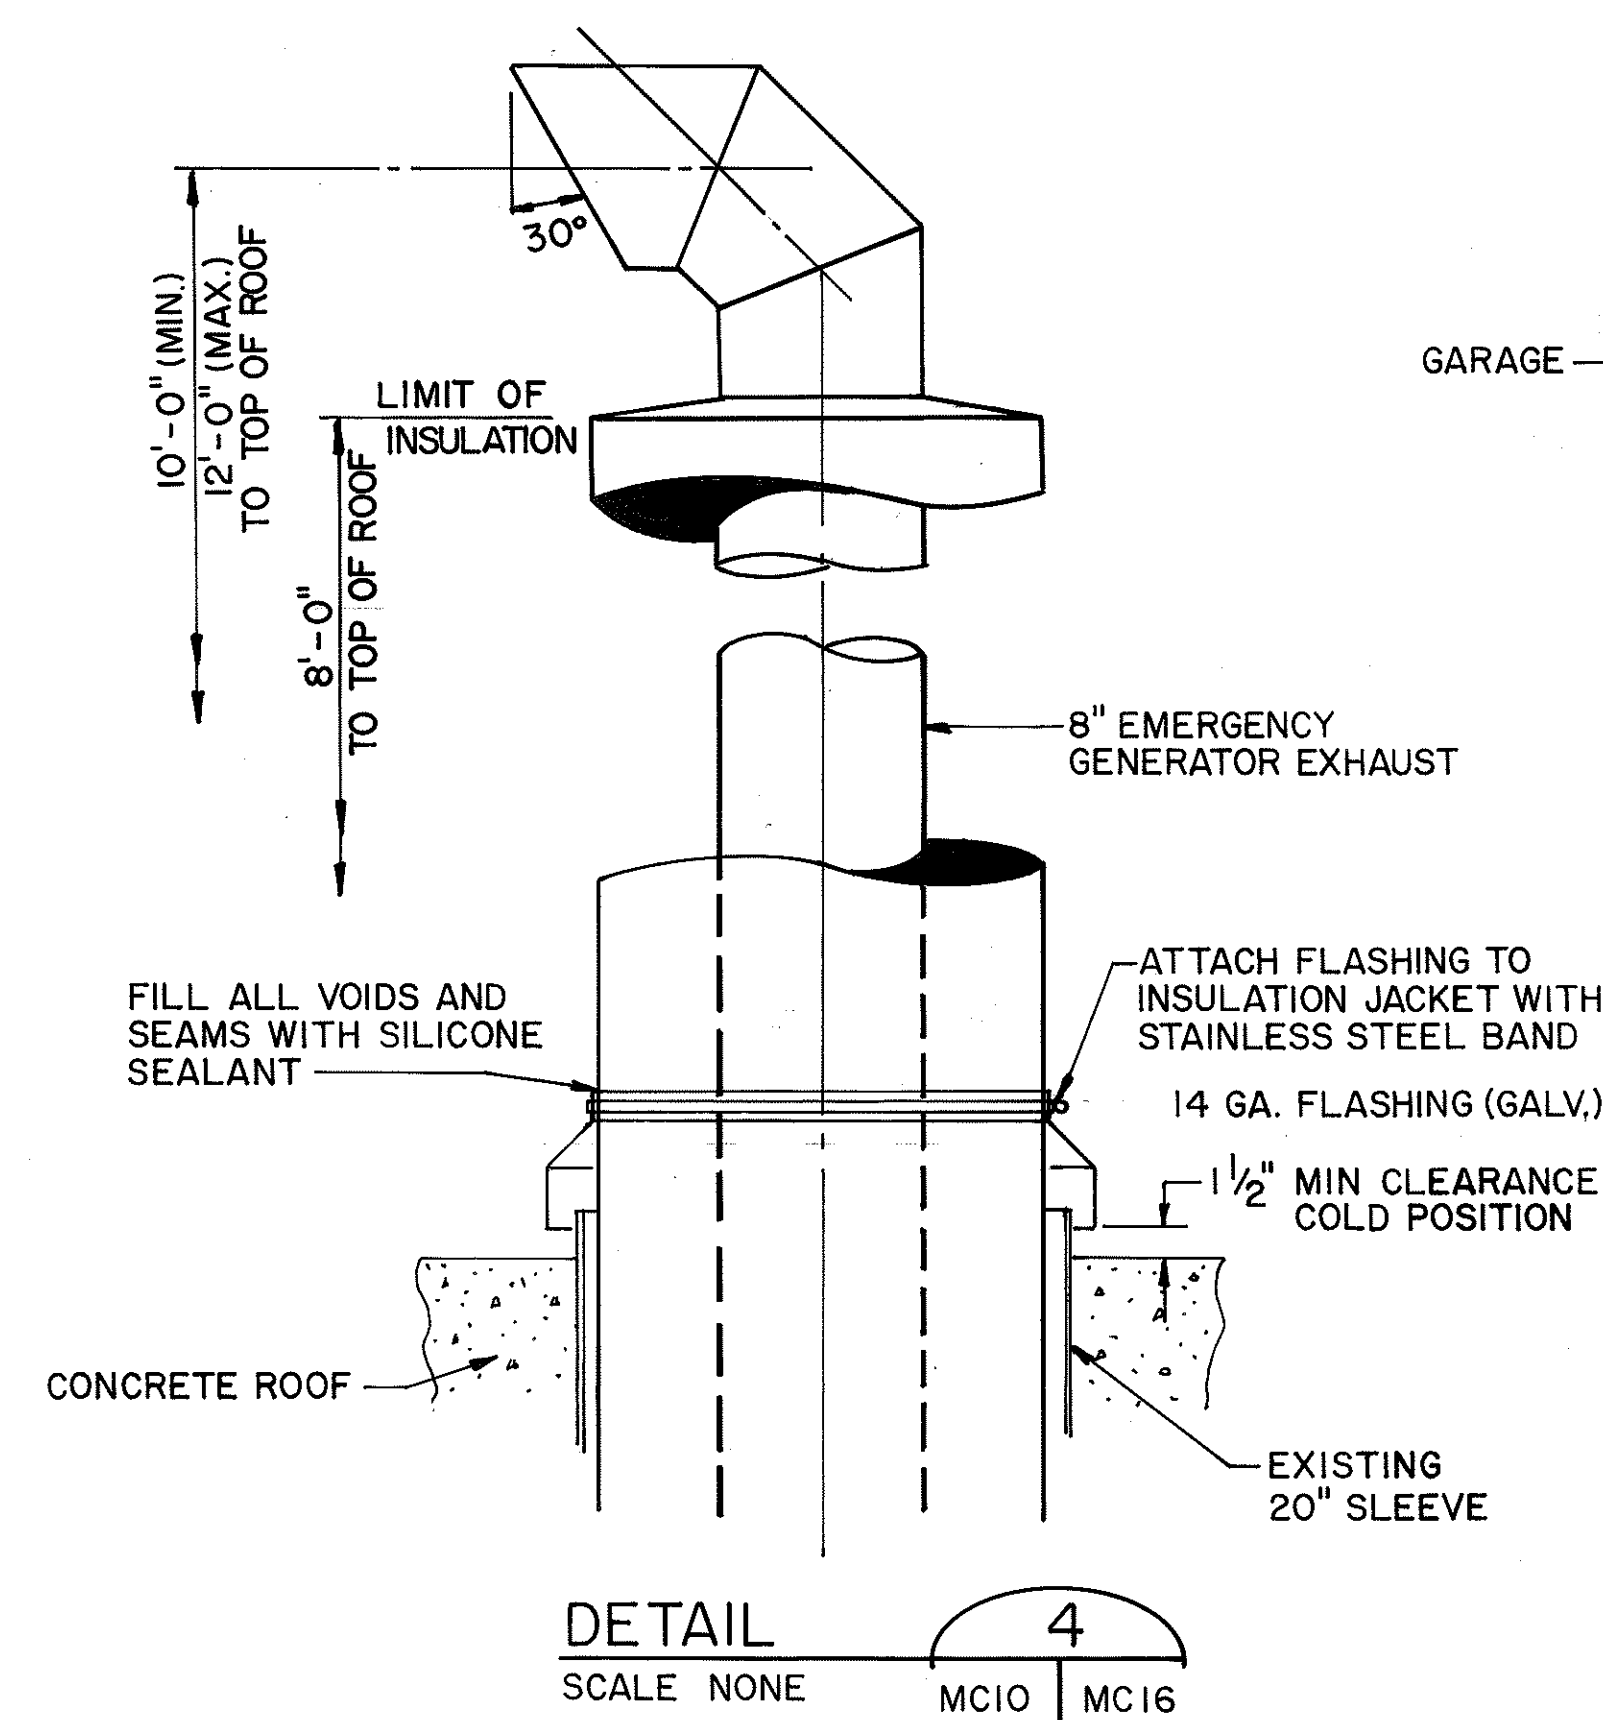

**FOR DETAIL AS-BUILT INFORMATION
REFER TO CONSTRUCTION SUBMITTALS**

4/15/94	REV. DETAIL 4 PER DCN 66-040
DATE	REVISION

STATE OF HAWAII
 DEPARTMENT OF TRANSPORTATION
 HIGHWAYS DIVISION

EMERGENCY GENERATOR


PLAN

CONTROL BUILDING

INTERSTATE ROUTE H-3
 F.A.I. PROJ. NO. I-H3-1 (66)



SCALE: 3/8"=1'-0"
DATE: APR 1992

SHEET NO. MC16 OF 19 SHEETS

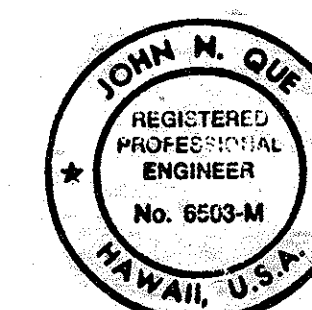


THIS WORK WAS PREPARED BY ME
OR UNDER MY SUPERVISION

John V. DeLoe

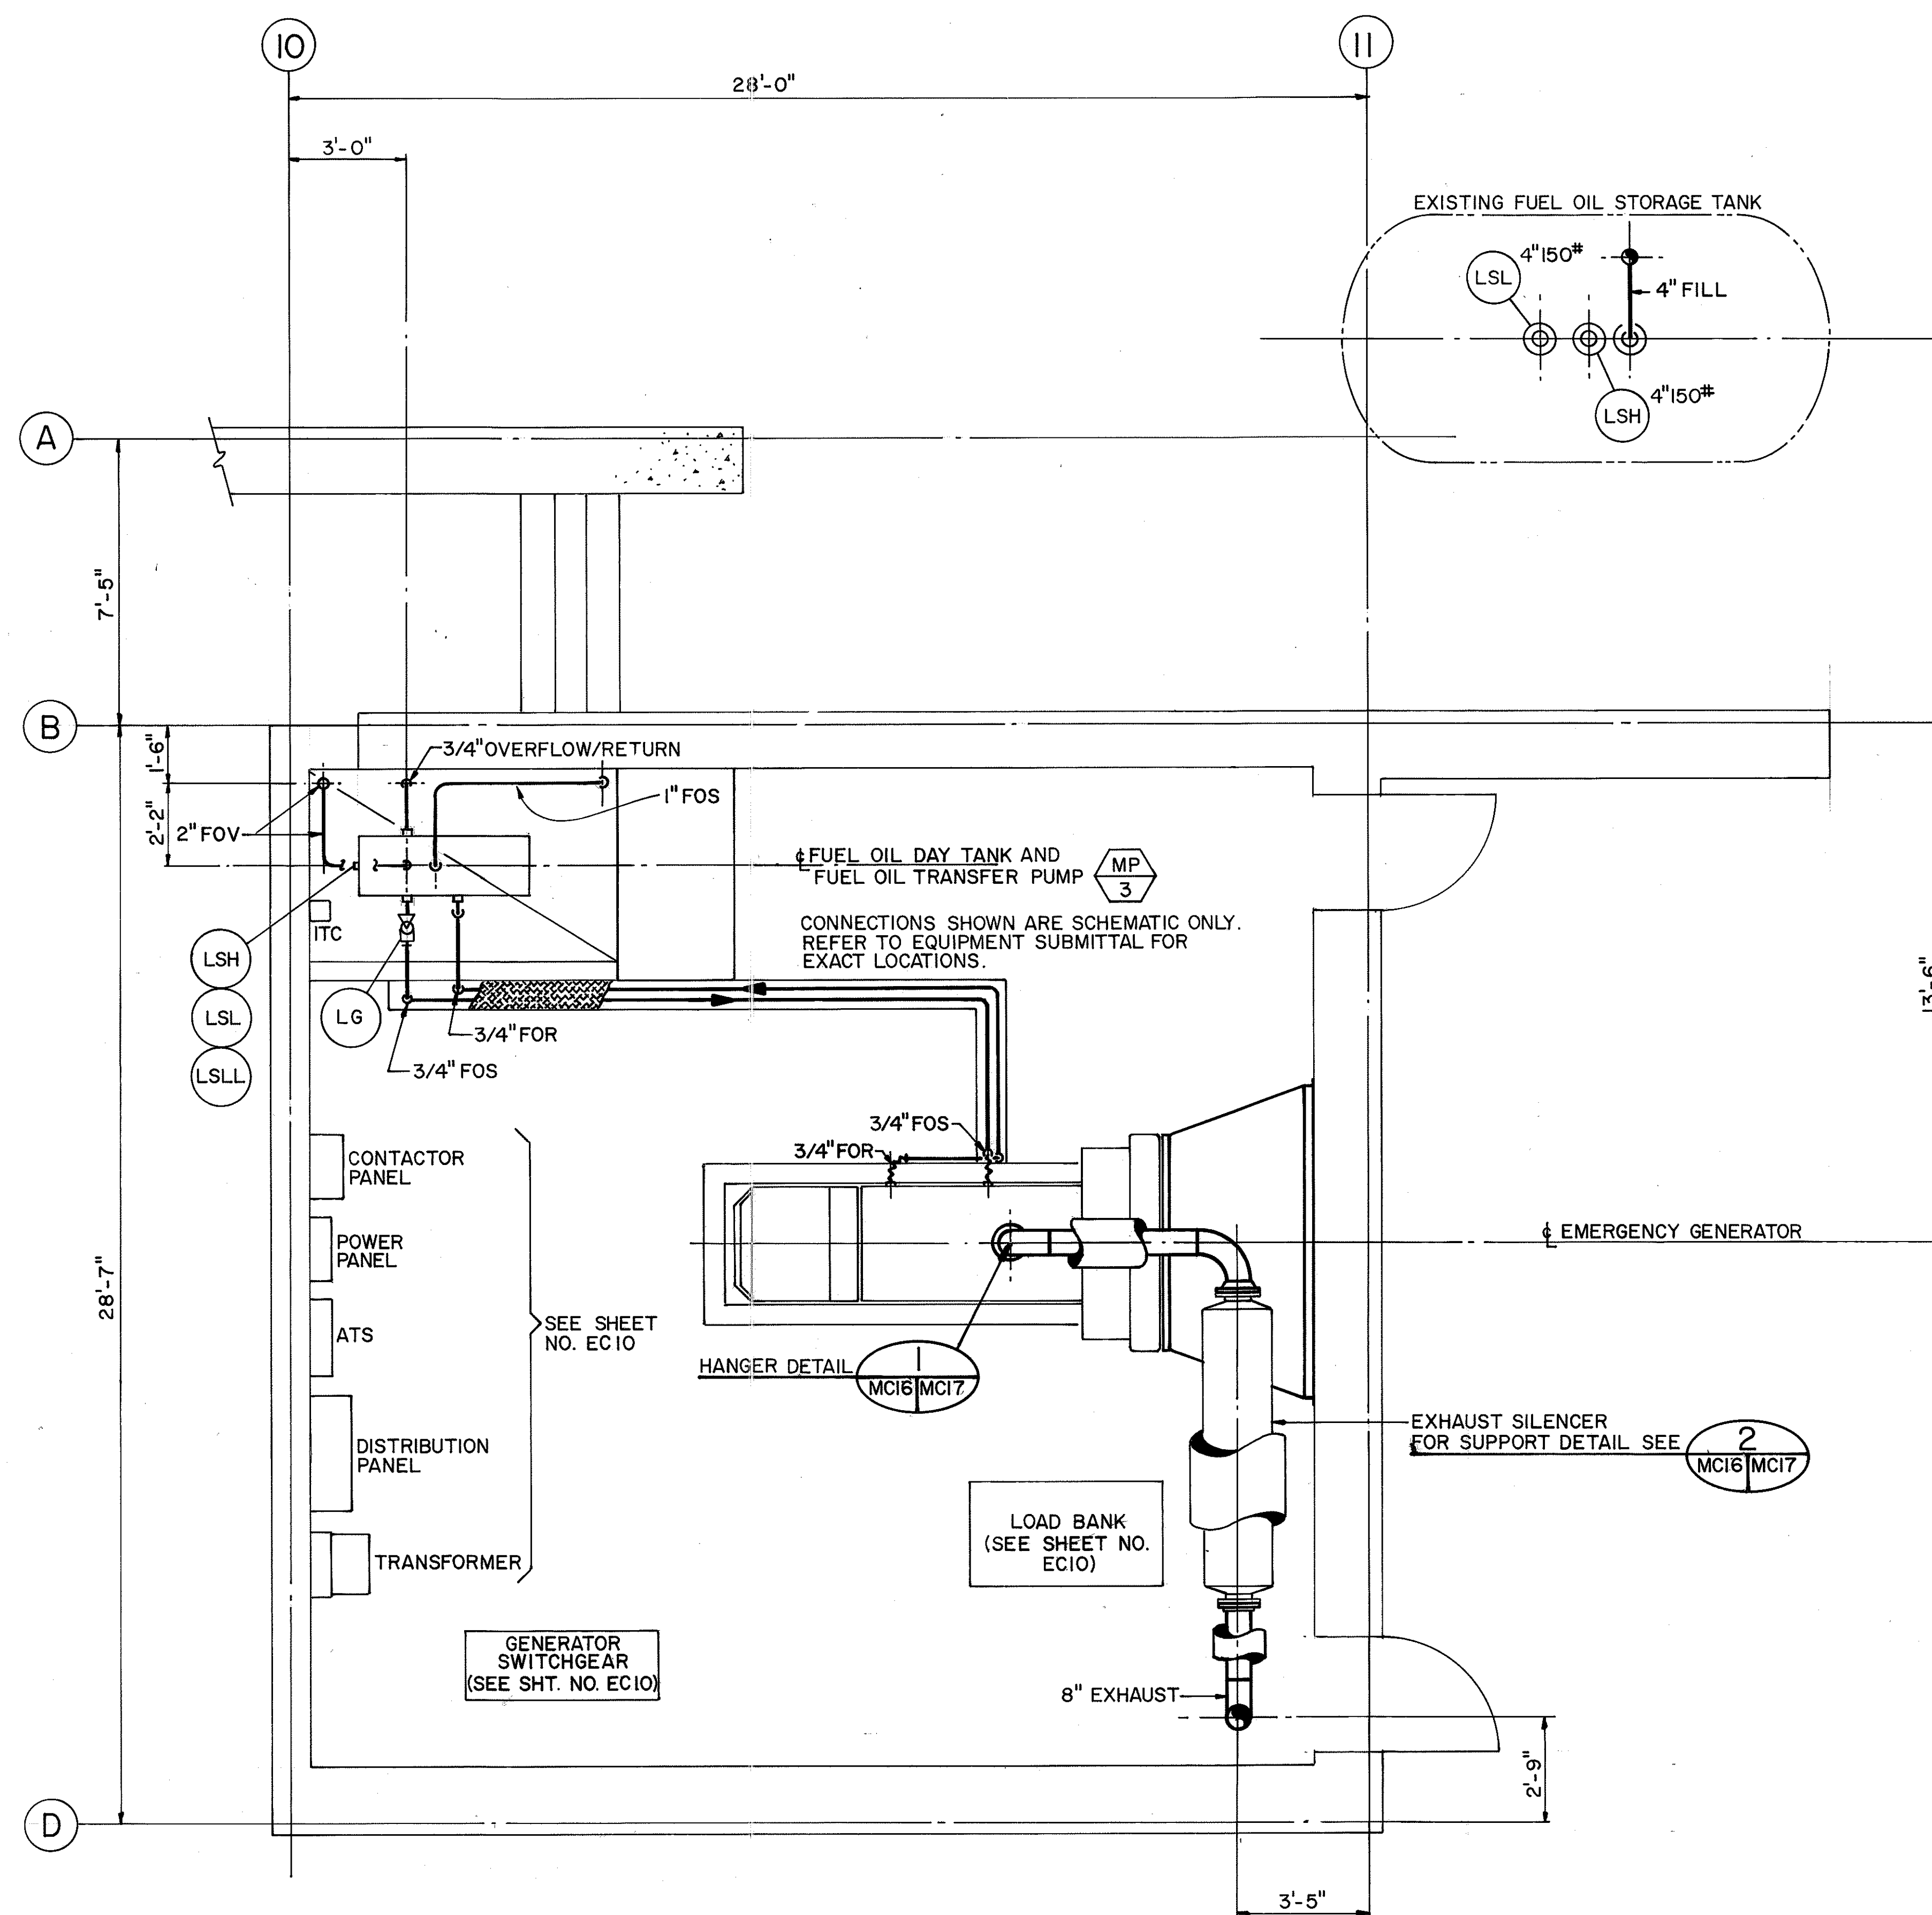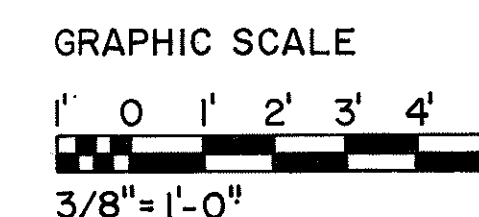


ORIGINAL PLAN	SURVEY PLOTTED BY <u>D. E. DRYDEN</u>	DATE <u>01/23/90</u>
NOTE BOOK	DRAWN BY _____	_____
	DESIGNED BY <u>D. E. DRYDEN</u>	<u>01/23/90</u>
	QUANTITIES BY _____	_____
No. _____	CHECKED BY <u>J. N. QUE</u>	<u>06/01/90</u>


FED. ROAD DIST. NO.	STATE	FED. AID PROJ. NO.	FISCAL YEAR	SHEET NO.	TOTAL SHEETS
HAWAII	HAW.	I-H3-1(66)	1992	72	440

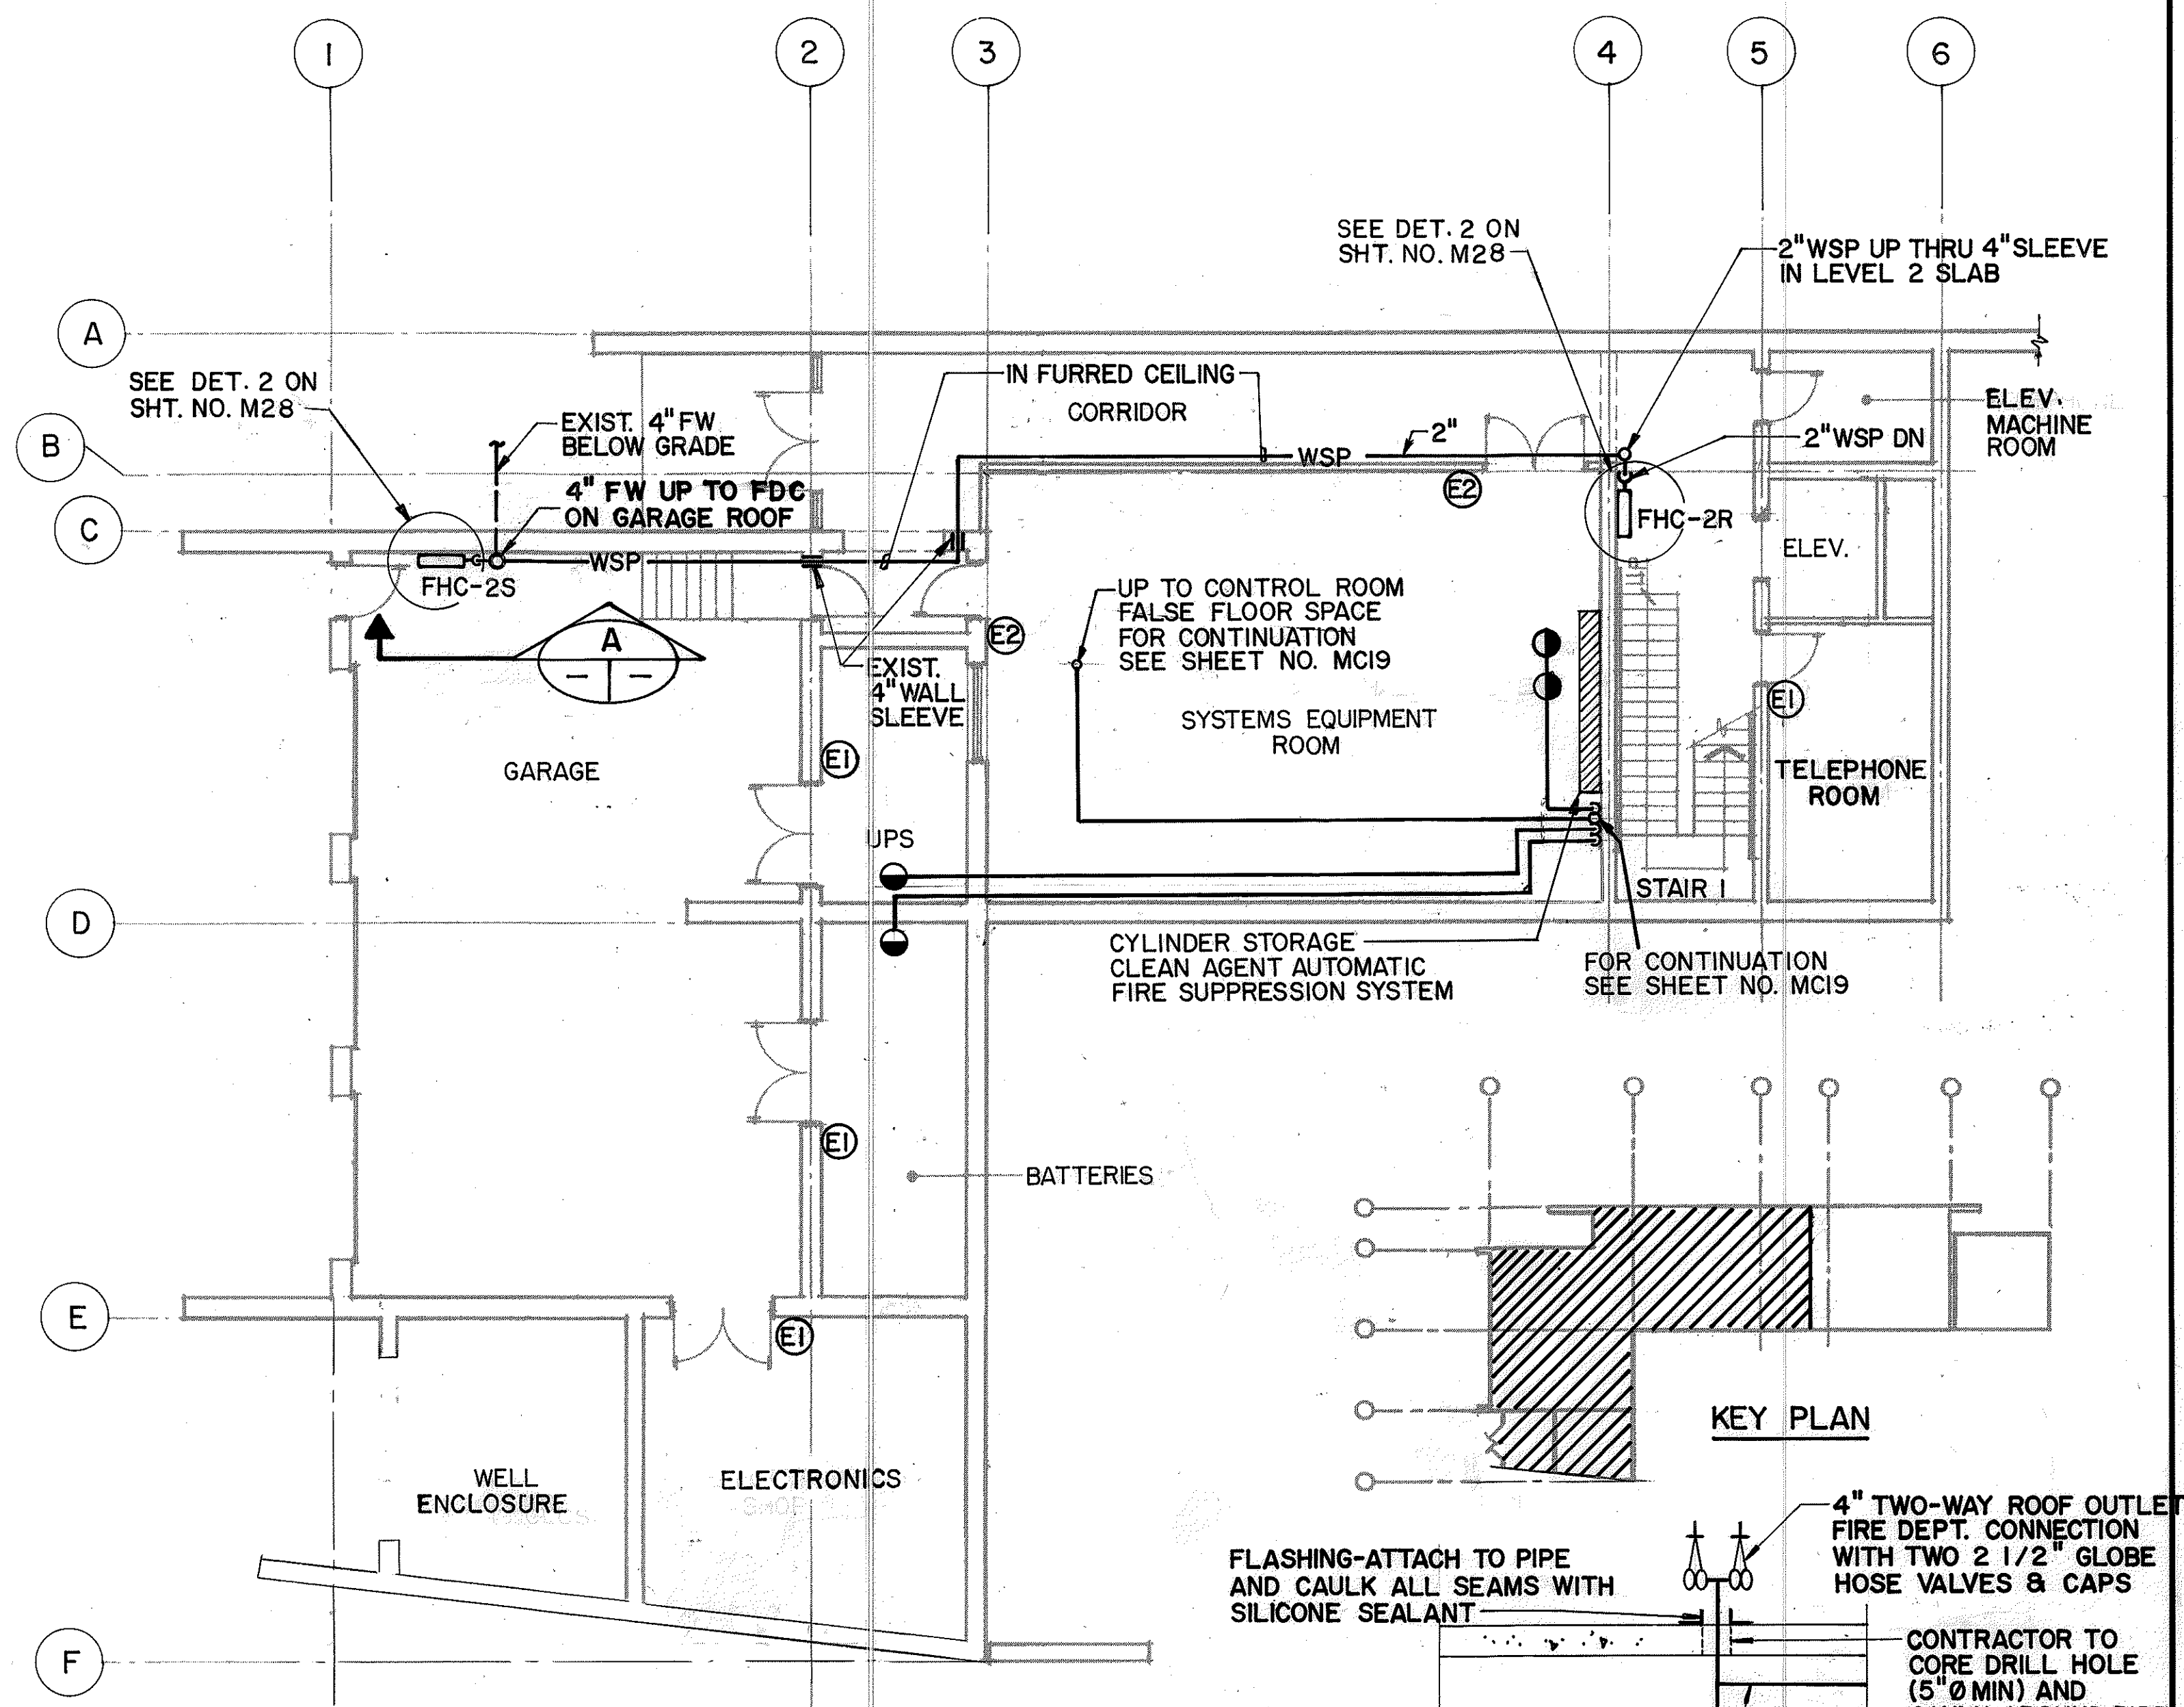


LEVEL 1 PLAN
SCALE: 1/8" = 1'-0"

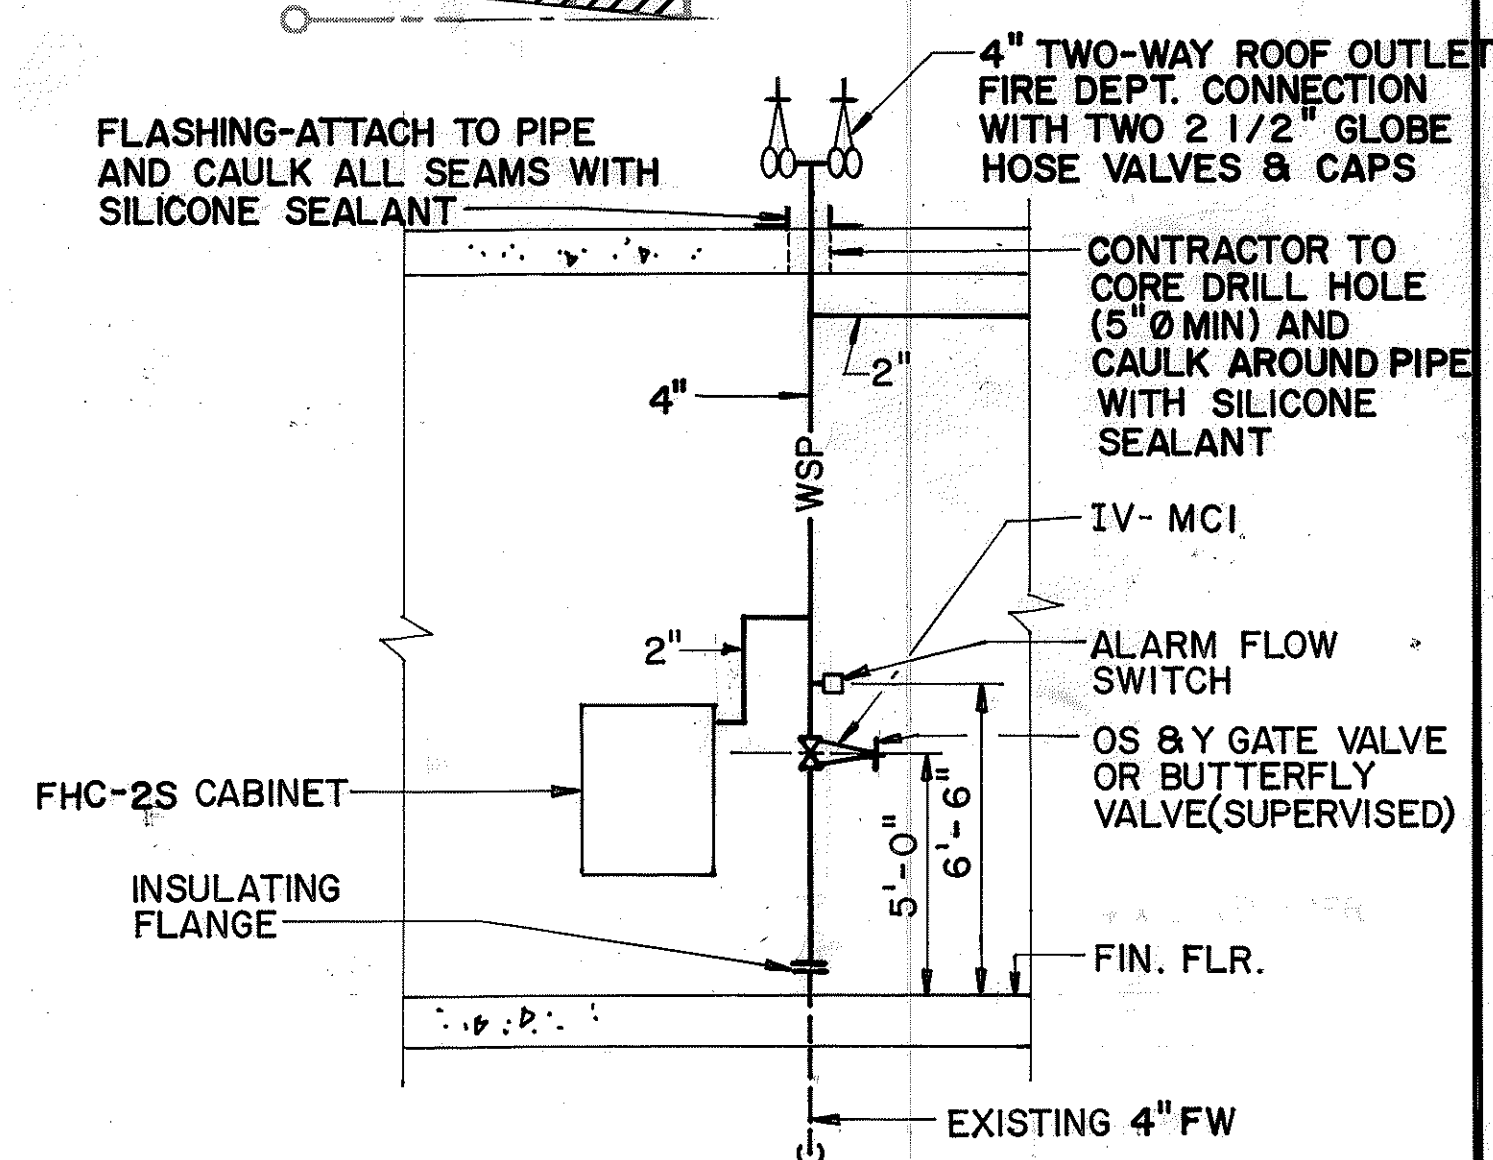

SECTION
SCALE: 1/4" = 1' - 0"

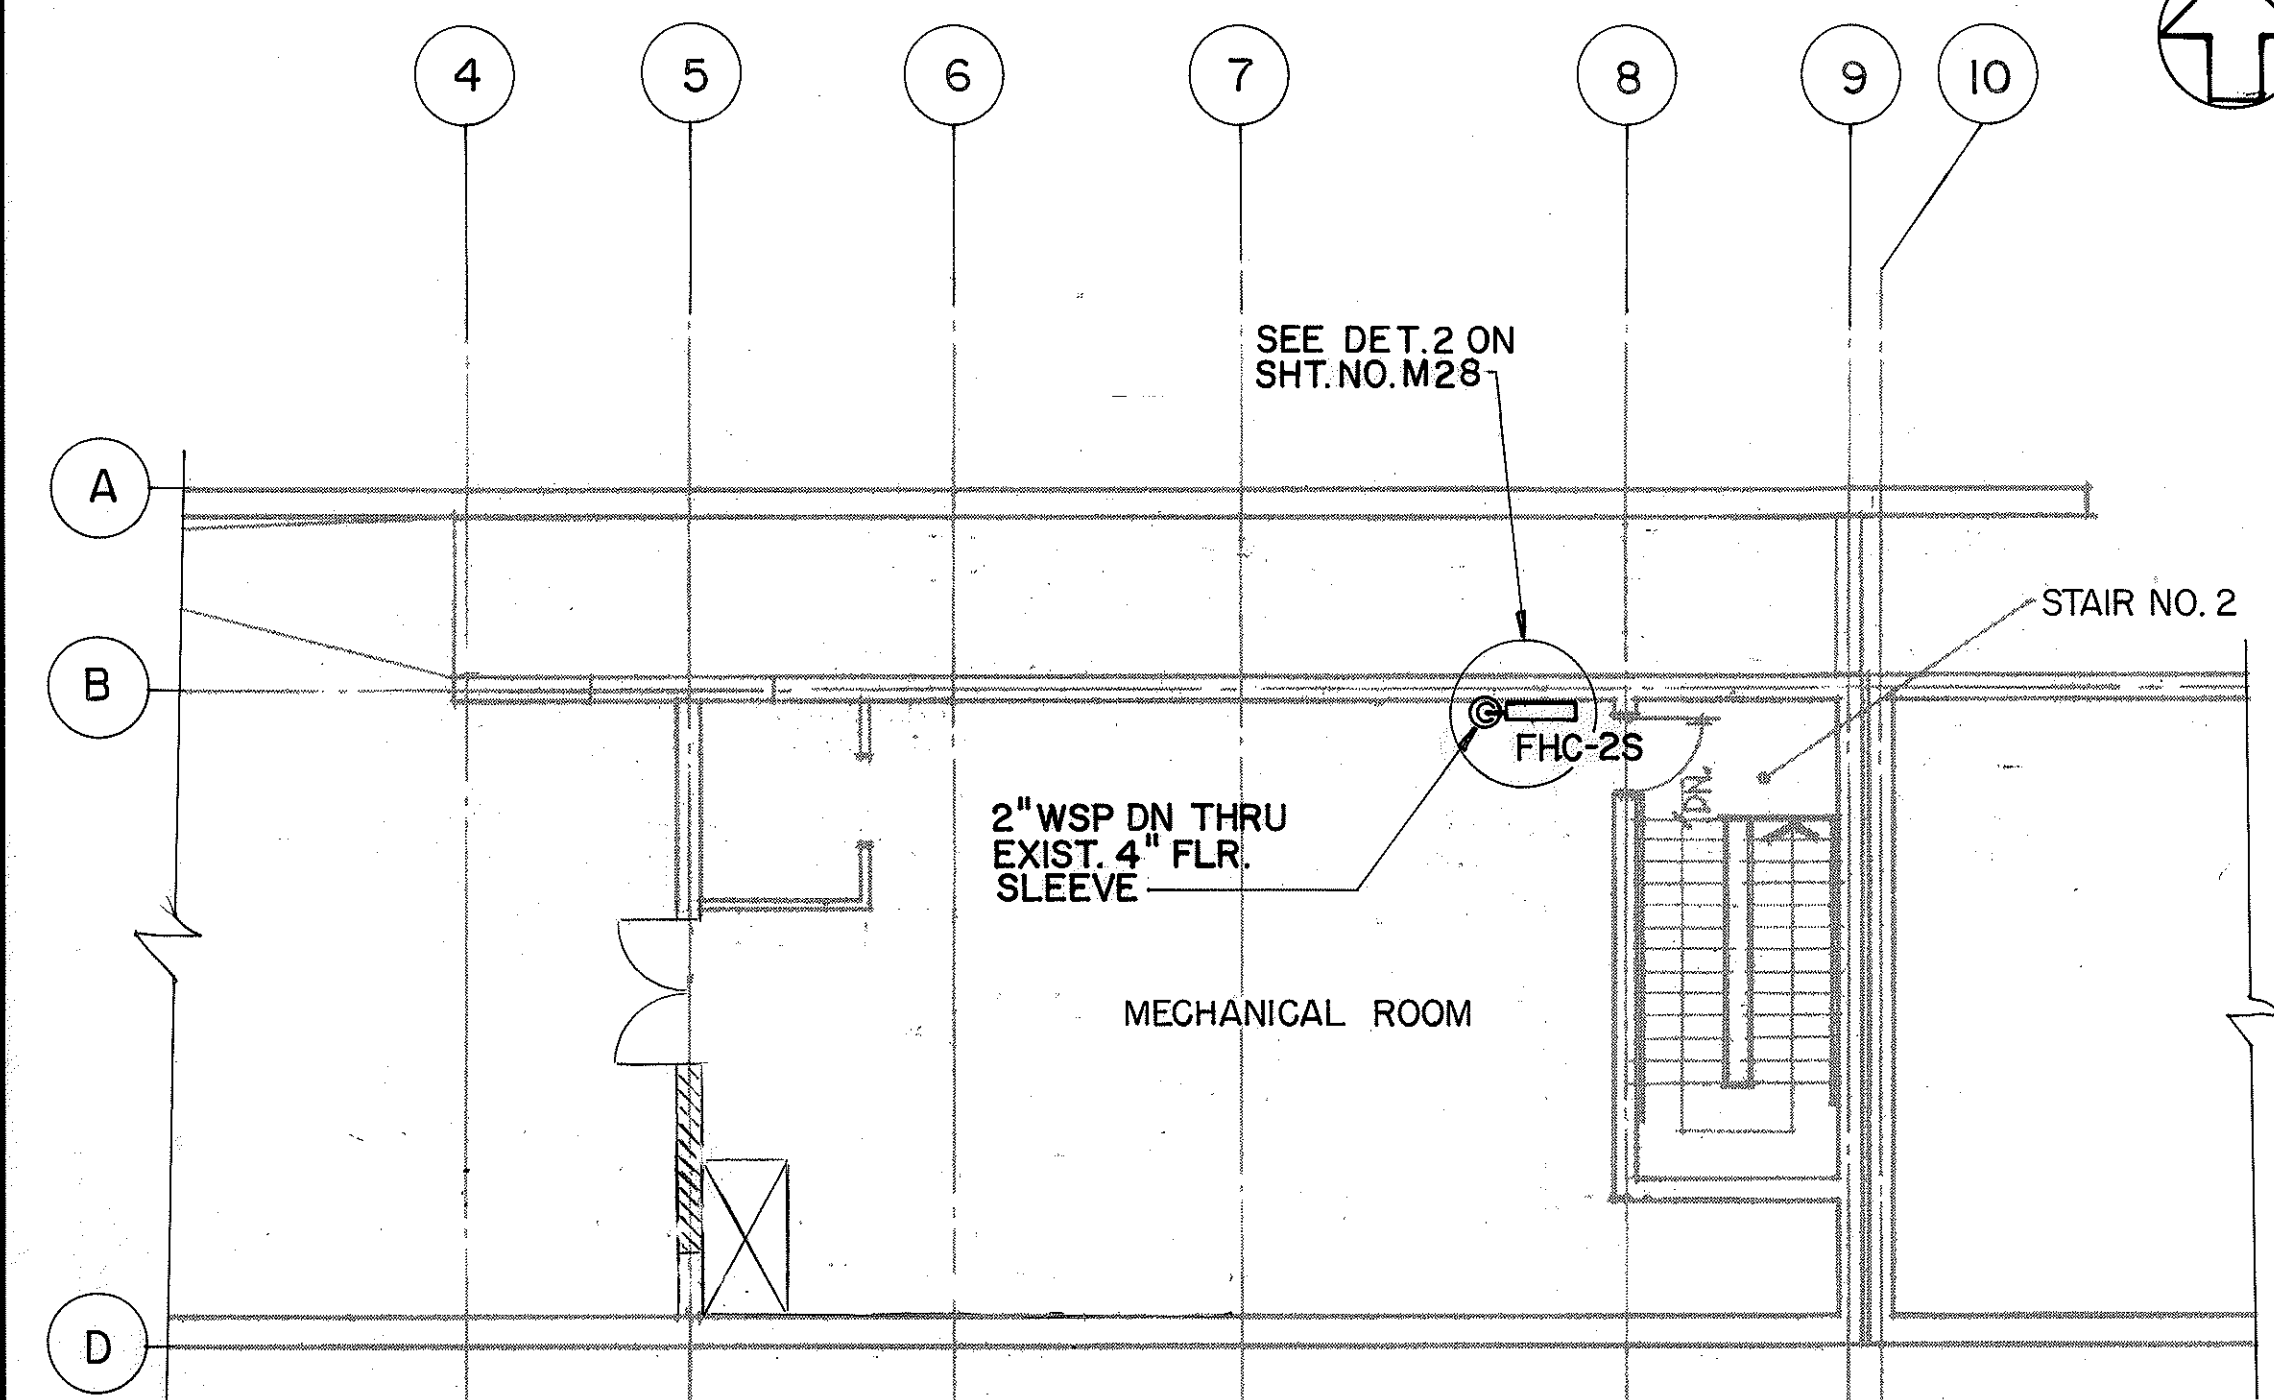

LEVEL 3 PARTIAL PLAN
SCALE: 1/8" = 1'-0"

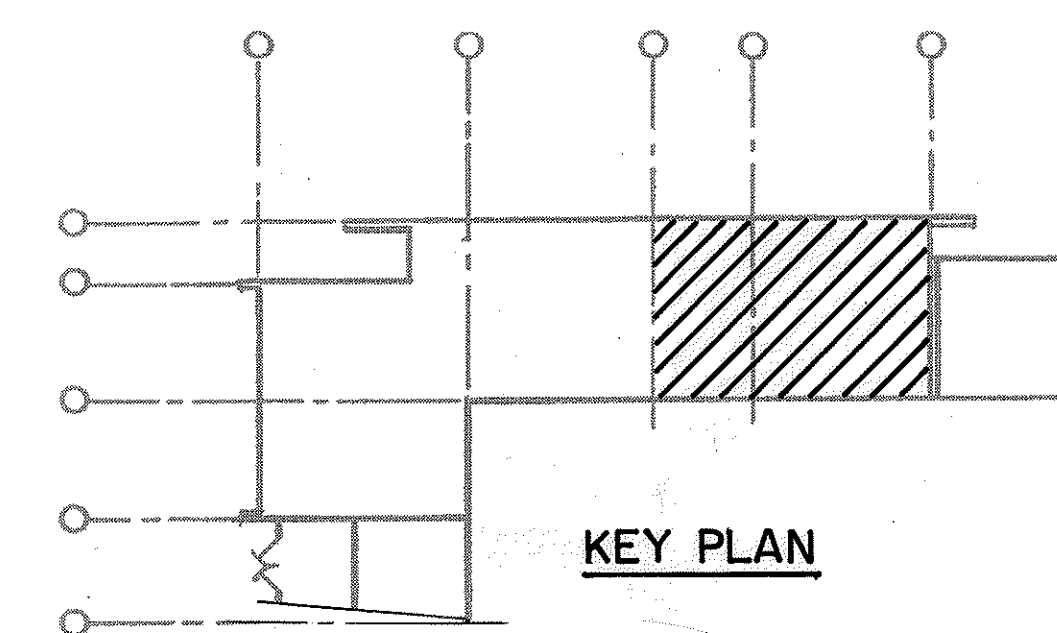

KEY PLAN

**FOR DETAIL AS-BUILT INFORMATION
REFER TO CONSTRUCTION SUBMITTALS**

6/21/94	REV. PER DCN 66-048
1/26/94	REV. PER DCN 66-034
6-15-93	ADDED FDC AT GARAGE ROOF PER
	DCN 66-011
DATE	REVISION

STATE OF HAWAII
 DEPARTMENT OF TRANSPORTATION
 HIGHWAYS DIVISION

FIRE PROTECTION-LEVEL 1 &
LEVEL 3 PLANS
CONTROL BUILDING
INTERSTATE ROUTE H-3
F.A.I. PROJ. NO. I-H3-1(66)

SCALE: AS NOTED
DATE: APR 1992



SHEET NO. MC18 OF 19 SHEETS




THIS WORK WAS PREPARED BY ME
OR UNDER MY SUPERVISION

John D.


FED. ROAD DIST. NO.	STATE	FED. AID PROJ. NO.	FISCAL YEAR	SHEET NO.	TOTAL SHEETS
HAWAII	HAW.	I-H3-1(66)	1992	73	440

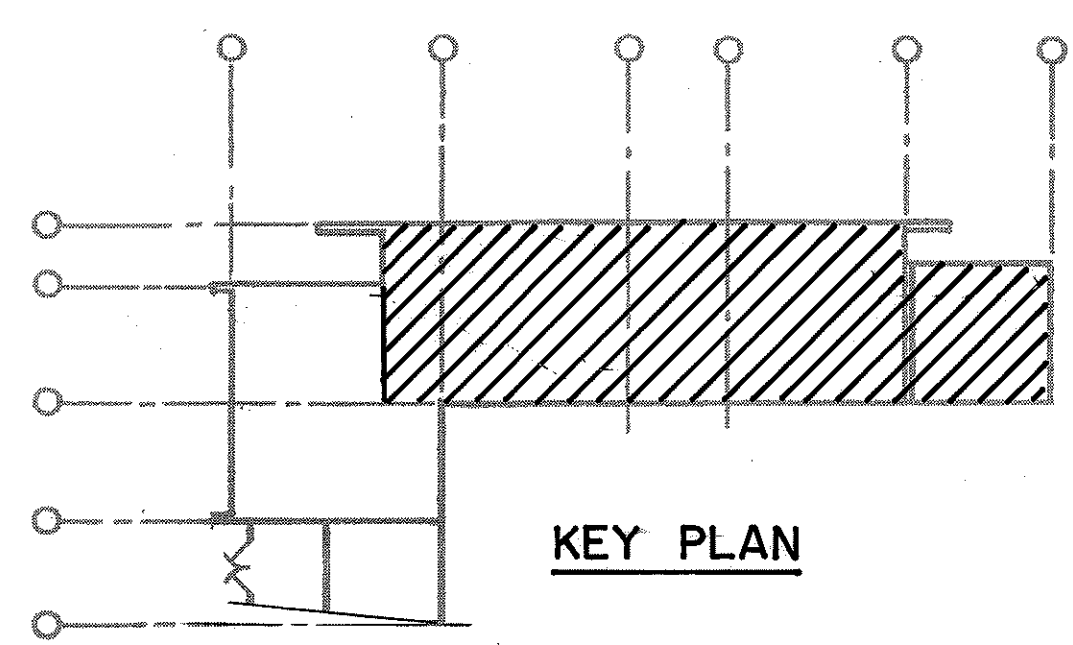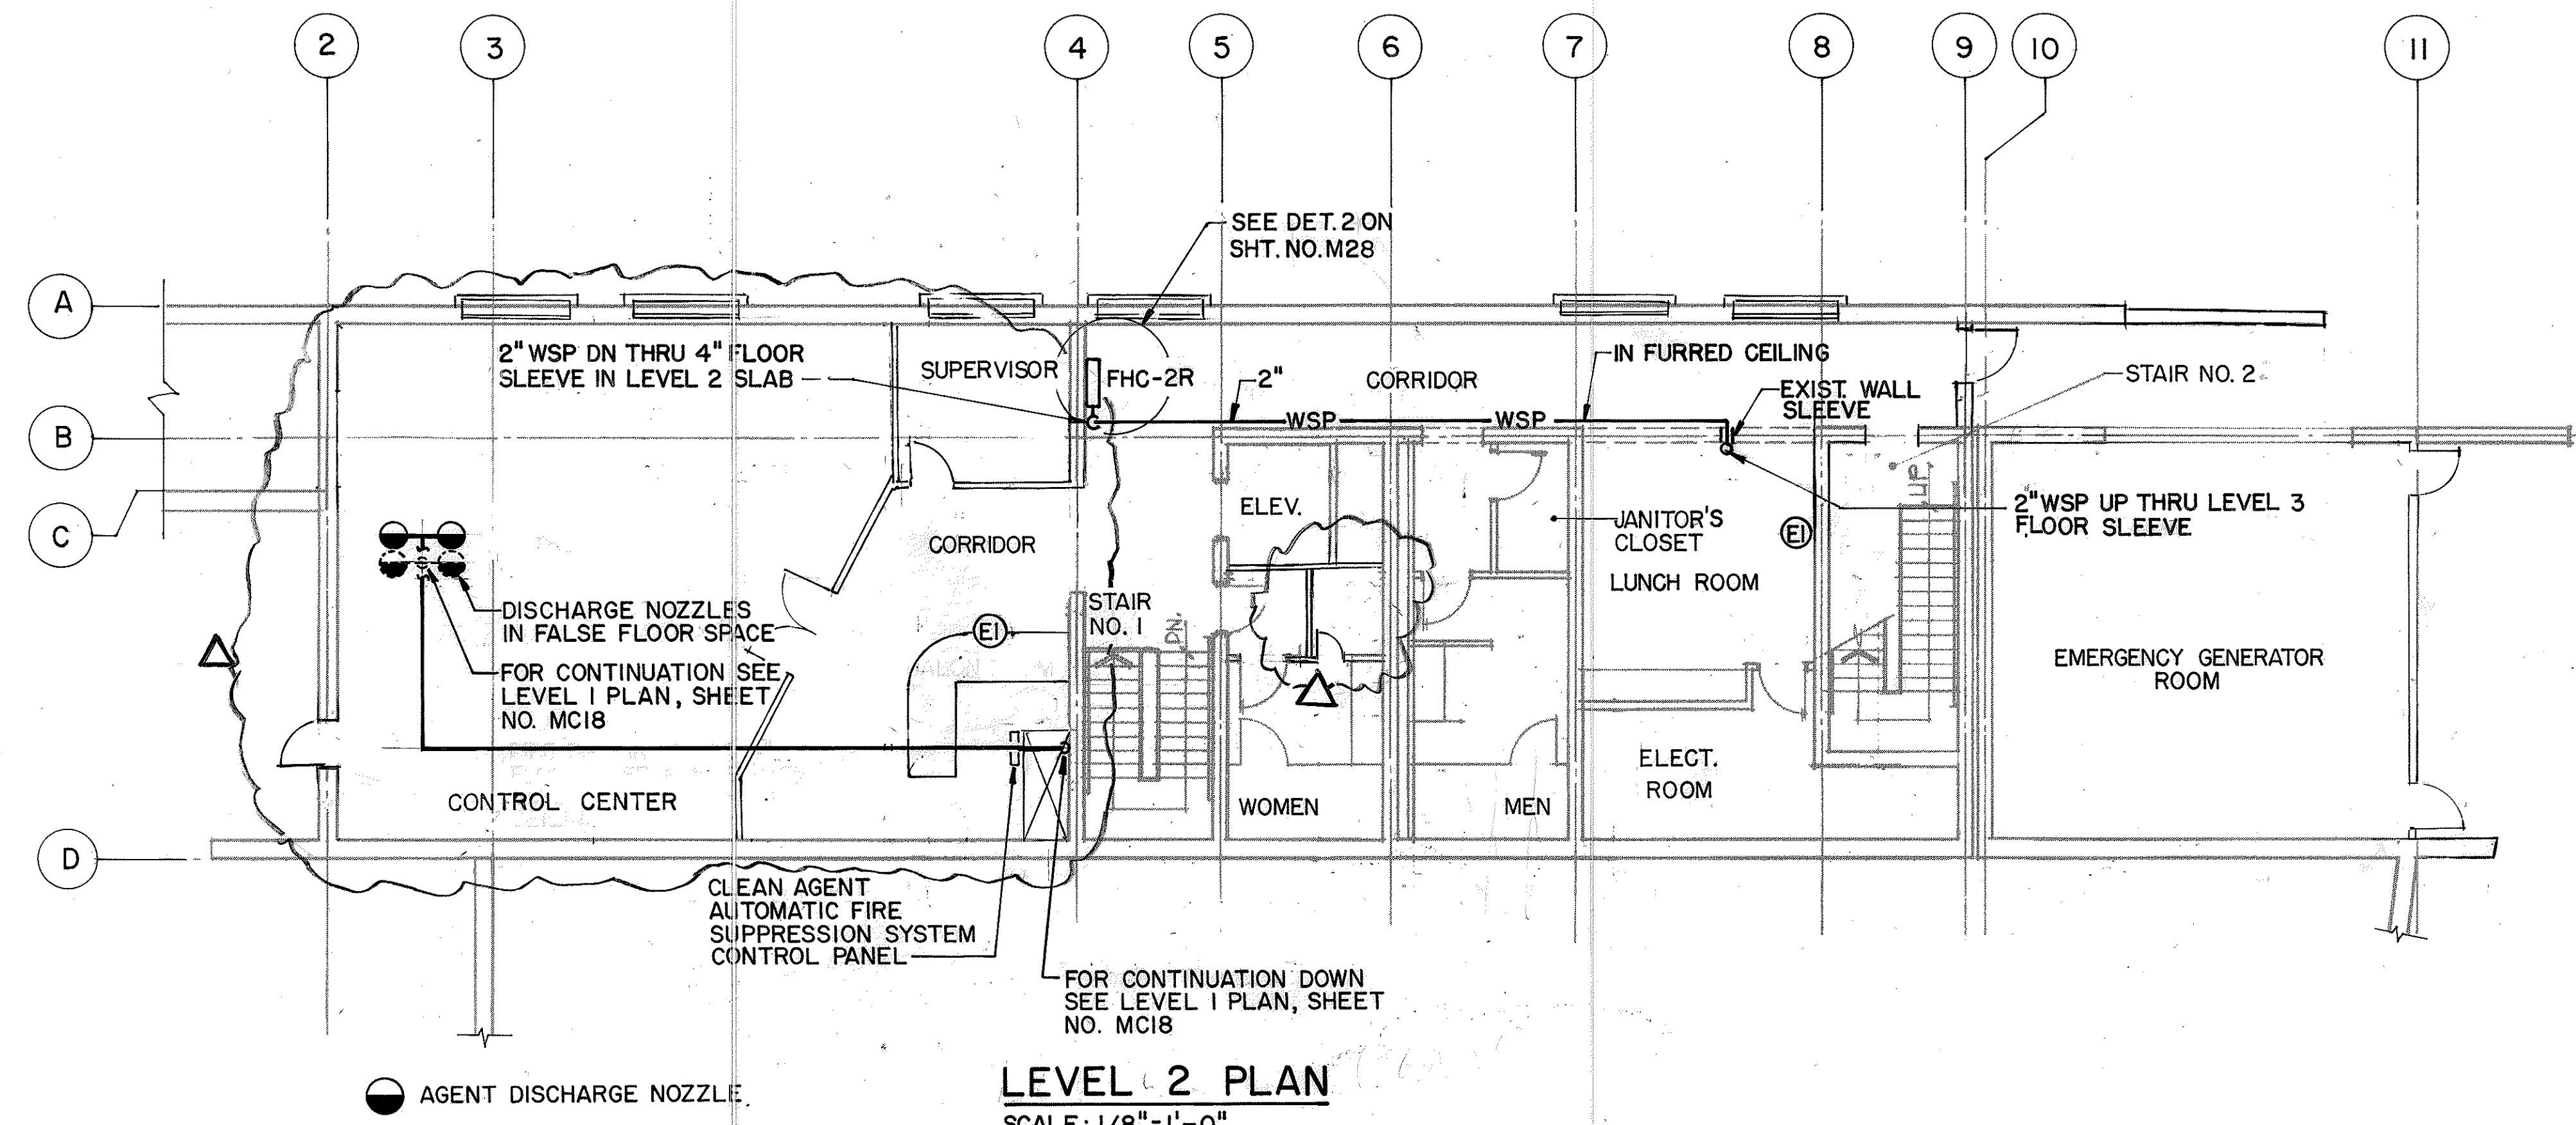

LEVEL 2 PLAN
SCALE: 1/8" = 1'-0"

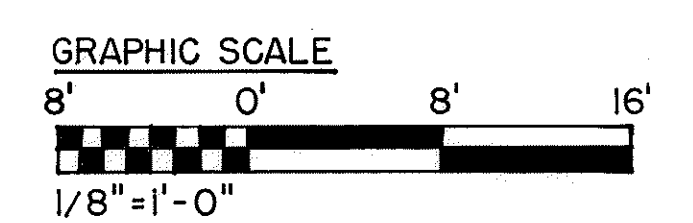

ORIGINAL PLAN	DATE
SURVEY PLOTTED BY	01/5/90
DRAWN BY	B. E. BUNY, JR.
DESIGNED BY	ELLALOU
CHECKED BY	J. N. QUE
DATE	06/01/90

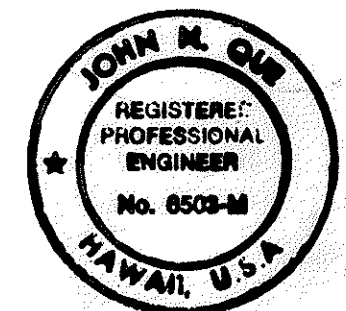


THIS WORK WAS PREPARED BY ME OR UNDER MY SUPERVISION

John M. Que

DATE	REVISION
12/9/94	REV. PER DCN 66-054A
6/21/94	REV. PER DCN 66-048
1/26/94	REV. PER DCN 66-034
DATE	REVISION
STATE OF HAWAII DEPARTMENT OF TRANSPORTATION HIGHWAYS DIVISION FIRE PROTECTION - LEVEL 2 PLAN CONTROL BUILDING INTERSTATE ROUTE H-3 F.A.I. PROJ. NO. I-H3-1(66)	
SCALE: 1/8" = 1'-0"	DATE: APR. 1992
SHEET NO. MC19 OF 19 SHEETS	

FED. ROAD DIST. NO.	STATE	FED. AID PROJ. NO.	FISCAL YEAR	SHEET NO.	TOTAL SHEETS
HAWAII	HAW.	I-H3-I(66)	1992	74	440

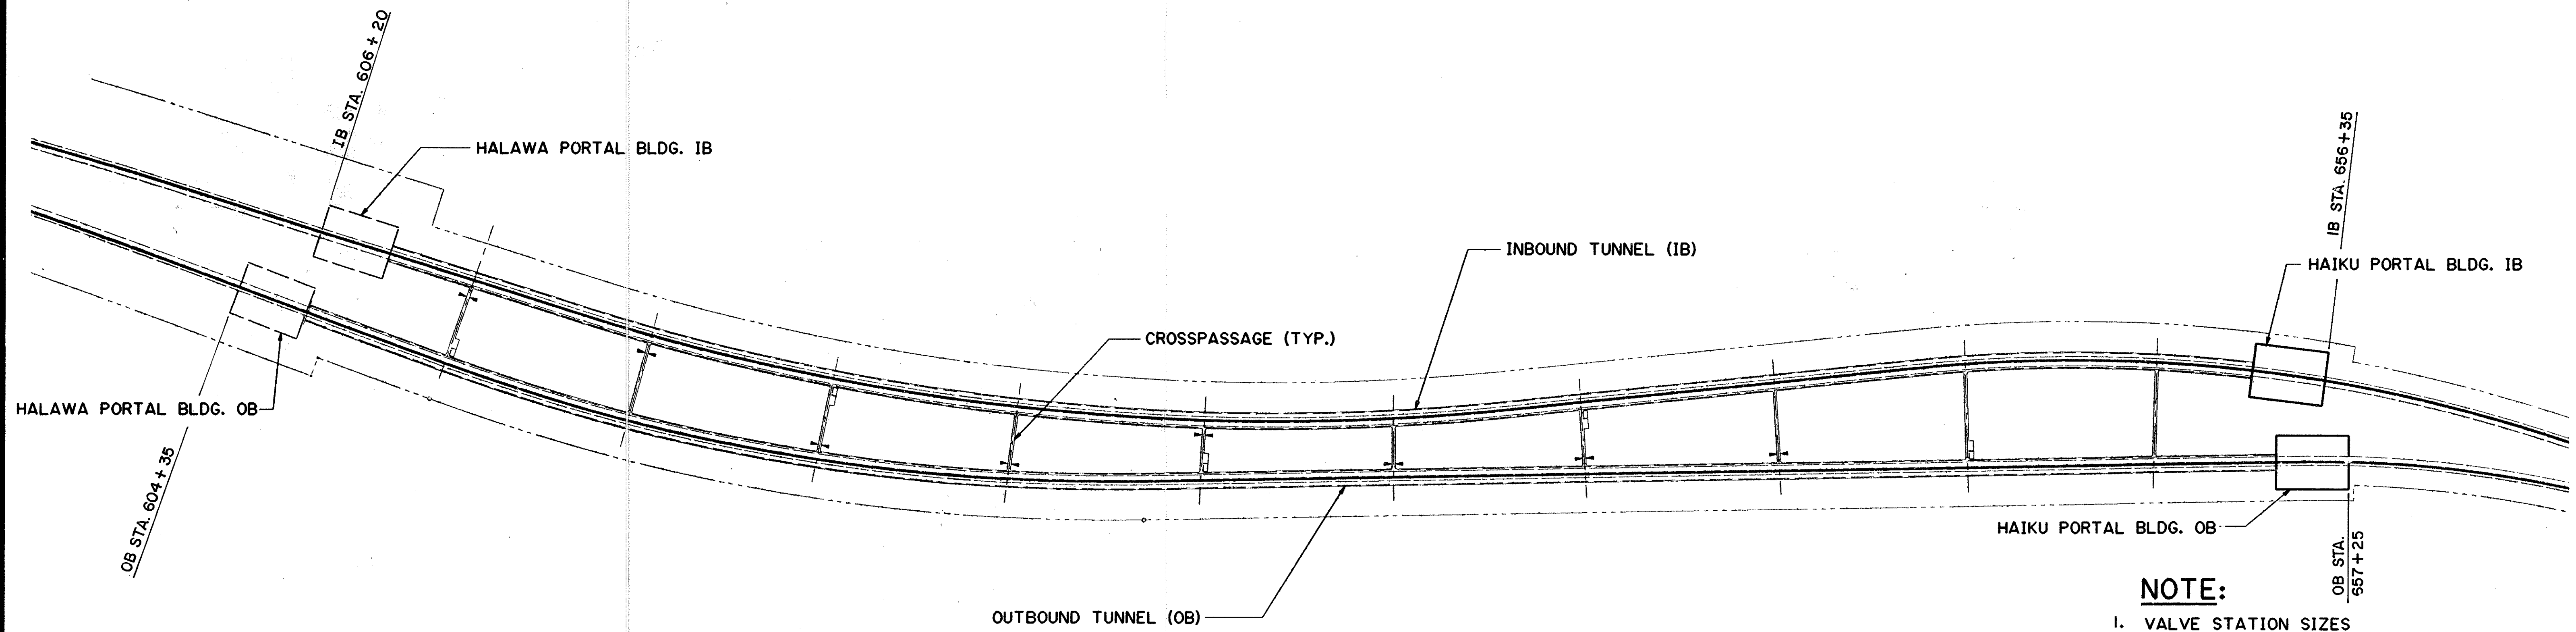

NOTE:

1. VALVE STATION SIZES
A = 4'-9" X 3'-3" HIGH
B = 3'-9" X 3'-3" HIGH
2. SEE DETAIL 1, SHT. NO. MT2 FOR VALVE STATION DETAIL.
3. SEE DETAIL 2, SHT. NO MT2 FOR VALVE BOX DETAIL

4. EACH VALVE STATION LOCATED AS SHOWN ON THIS PLAN REQUIRES THE INSTALLATION OF ONE FIRE EXTINGUISHER, HOSE AND RACK AS DETAILED ON SHEET NO. MT2.
5. THIS PLAN IS FOR REFERENCE ONLY AND SHOWS NUMBER AND LOCATION OF VALVE STATIONS WITHIN THE TUNNEL.


FOR DETAIL AS-BUILT INFORMATION
REFER TO CONSTRUCTION SUBMITTALS

IB TUNNEL				
VS NO.	VS LOCATION	VS SIZE	VB LOCATION	VB NO.
1	606+17	B	-	
2	607+20	B	-	
3	608+45	A	608+44.25	1
4	609+70	B	-	
5	610+95	B	-	
6	612+03.708	B	-	
7	613+30	A	613+29.25	2
8	614+55	B	-	
9	615+80	B	-	
10	616+88.708	B	-	
11	618+15	A	618+14.25	3
12	619+40	B	-	
13	620+65	B	-	
14	621+73.708	B	-	
15	623+00	A	622+99.25	4
16	624+25	B	-	
17	625+50	B	-	
18	626+58.708	B	-	
19	627+85	A	627+84.25	5
20	629+10	B	-	
21	630+35	B	-	
22	631+48.708	B	-	
23	632+75	A	632+74.25	6
24	634+00	B	-	
25	635+25	B	-	

IB TUNNEL				
VS NO.	VS LOCATION	VS SIZE	VB LOCATION	VB NO.
26	636+38.708	B	-	
27	637+65	A	637+64.25	7
28	638+90	B	-	
29	640+15	B	-	
30	641+38.708	B	-	
31	642+65	A	642+64.25	8
32	643+90	B	-	
33	645+15	B	-	
34	646+38.708	B	-	
35	647+65	A	647+64.25	9
36	648+90	B	-	
37	650+15	B	-	
38	651+38.708	B	-	
39	652+65	A	652+64.25	10
40	653+90	B	-	
41	655+13	B	-	

OB TUNNEL				
VS NO.	VS LOCATION	VS SIZE	VB LOCATION	VB NO.
1	604+32	B	-	
2	605+60	B	-	
3	606+85	B	-	
4	608+10	A	608+09.25	1
5	609+35	B	-	
6	610+60	B	-	
7	611+83.708	B	-	
8	613+10	A	613+09.25	2
9	614+35	B	-	
10	615+60	B	-	
11	616+83.708	B	-	
12	618+10	A	618+09.25	3
13	619+35	B	-	
14	620+60	B	-	
15	621+83.708	B	-	
16	623+10	A	623+09.25	4
17	624+35	B	-	
18	625+60	B	-	
19	626+83.708	B	-	
20	628+10	A	628+09.25	5
21	629+35	B	-	
22	630+60	B	-	
23	631+83.708	B	-	
24	633+10	A	633+09.25	6
25	634+35	B	-	

OB TUNNEL				
VS NO.	VS LOCATION	VS SIZE	VB LOCATION	VB NO.
26	635+60	B	-	
27	636+83.708	B	-	
28	638+10	A	638+09.25	7
29	639+35	B	-	
30	640+60	B	-	
31	641+83.708	B	-	
32	643+10	A	643+09.25	8
33	644+35	B	-	
34	645+60	B	-	
35	646+73.708	B	-	
36	648+00	A	647+99.25	9
37	649+25	B	-	
38	650+50	B	-	
39	651+58.708	B	-	
40	652+85	A	652+84.25	10
41	654+10	B	-	
42	655+35	B	-	
43	656+03	B	-	

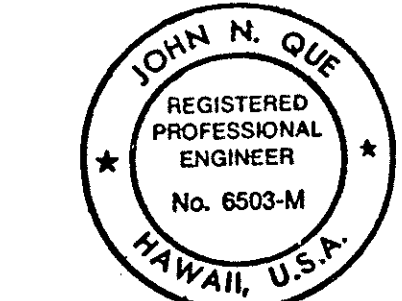


THIS WORK WAS PREPARED BY ME
OR UNDER MY SUPERVISION

John N. Que


REVISION	
DATE	REVISION
STATE OF HAWAII DEPARTMENT OF TRANSPORTATION HIGHWAYS DIVISION	
VALVE STATION LOCATION PLAN TUNNELS	
INTERSTATE ROUTE H-3 F.A.I. PROJ. NO. I-H3-I(66)	
SCALE: NONE	DATE: APR 1992
SHEET NO. MT1	OF 3 SHEETS

ORIGINAL PLAN	DATE 4/19/92
NO. 1	
NO. 2	
NO. 3	
NO. 4	
NO. 5	
NO. 6	
NO. 7	
NO. 8	
NO. 9	
NO. 10	
NO. 11	
NO. 12	
NO. 13	
NO. 14	
NO. 15	
NO. 16	
NO. 17	
NO. 18	
NO. 19	
NO. 20	
NO. 21	
NO. 22	
NO. 23	
NO. 24	
NO. 25	


FED. ROAD DIST. NO.	STATE	FED. AID PROJ. NO.	FISCAL YEAR	SHEET NO.	TOTAL SHEETS
HAWAII	HAW.	I-H3-1(66)	1992	75	440

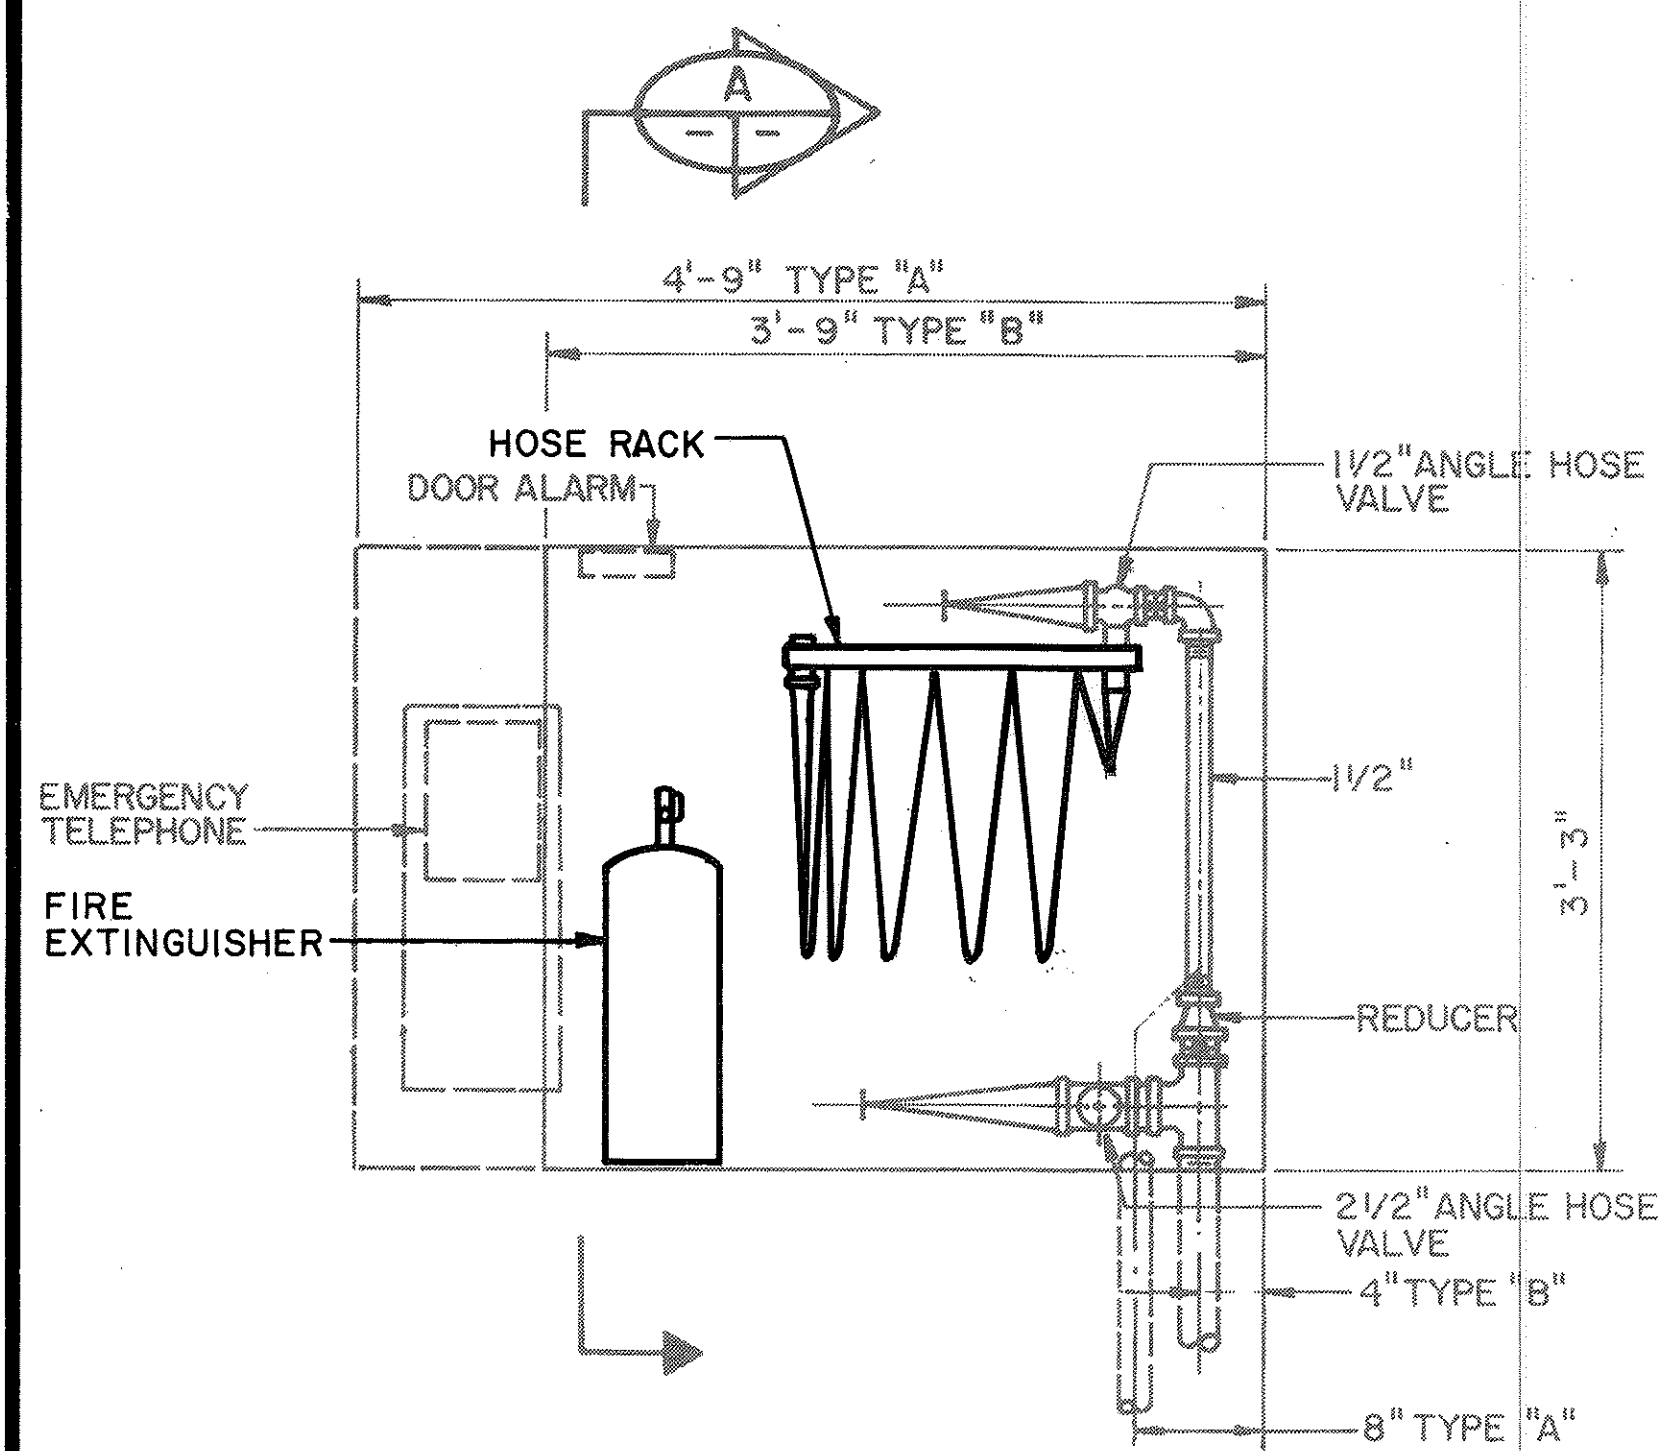



FRONT VIEW

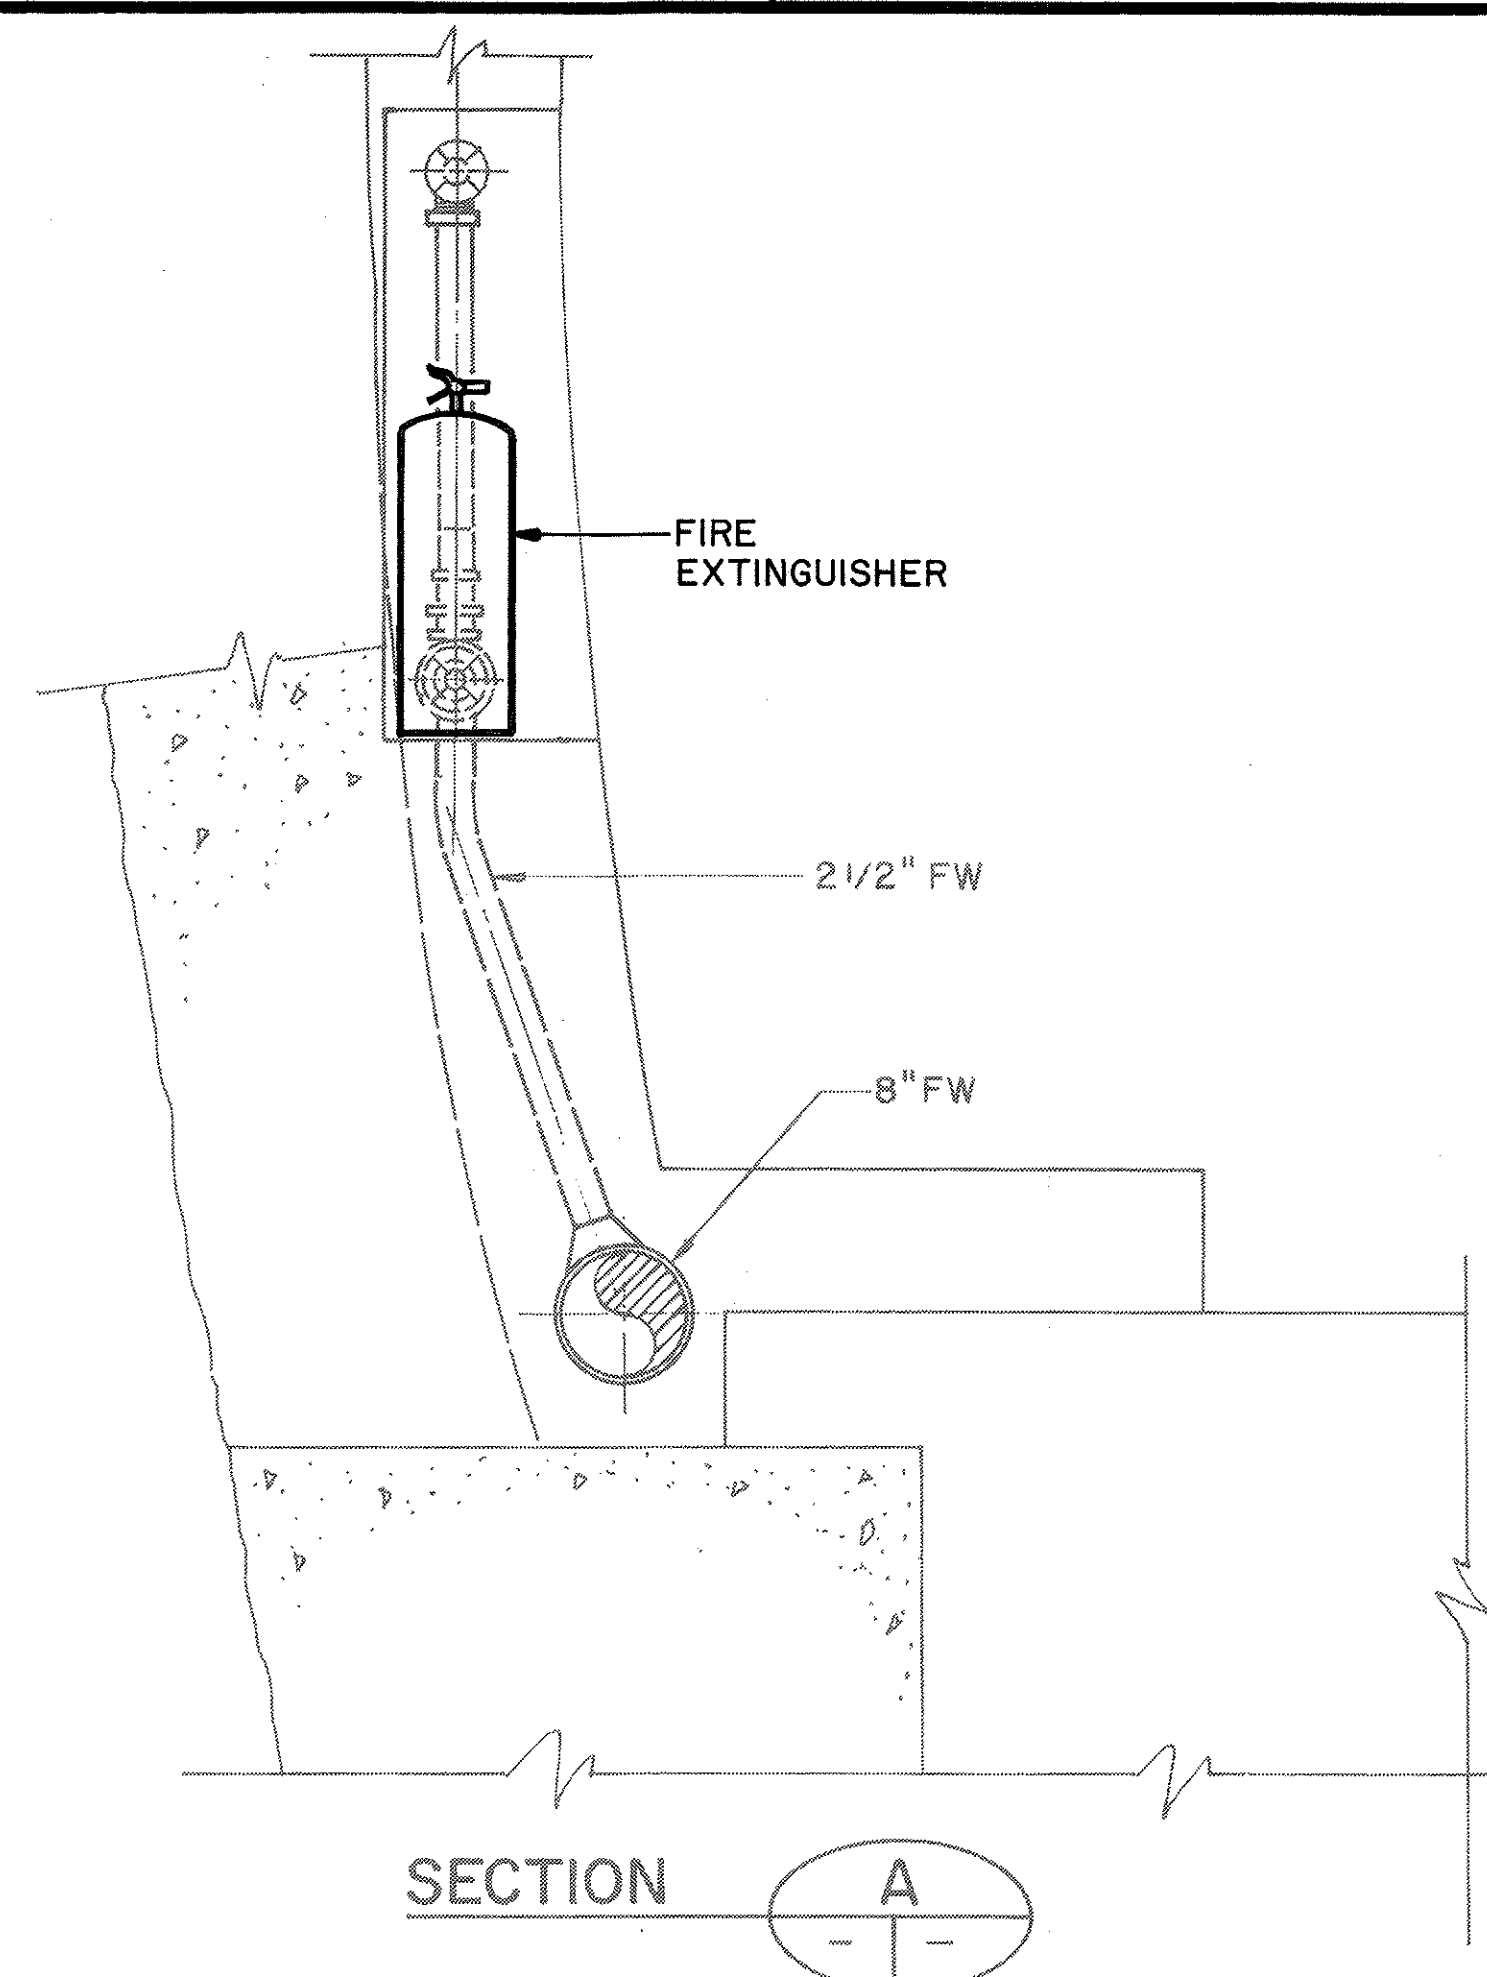

SECTION

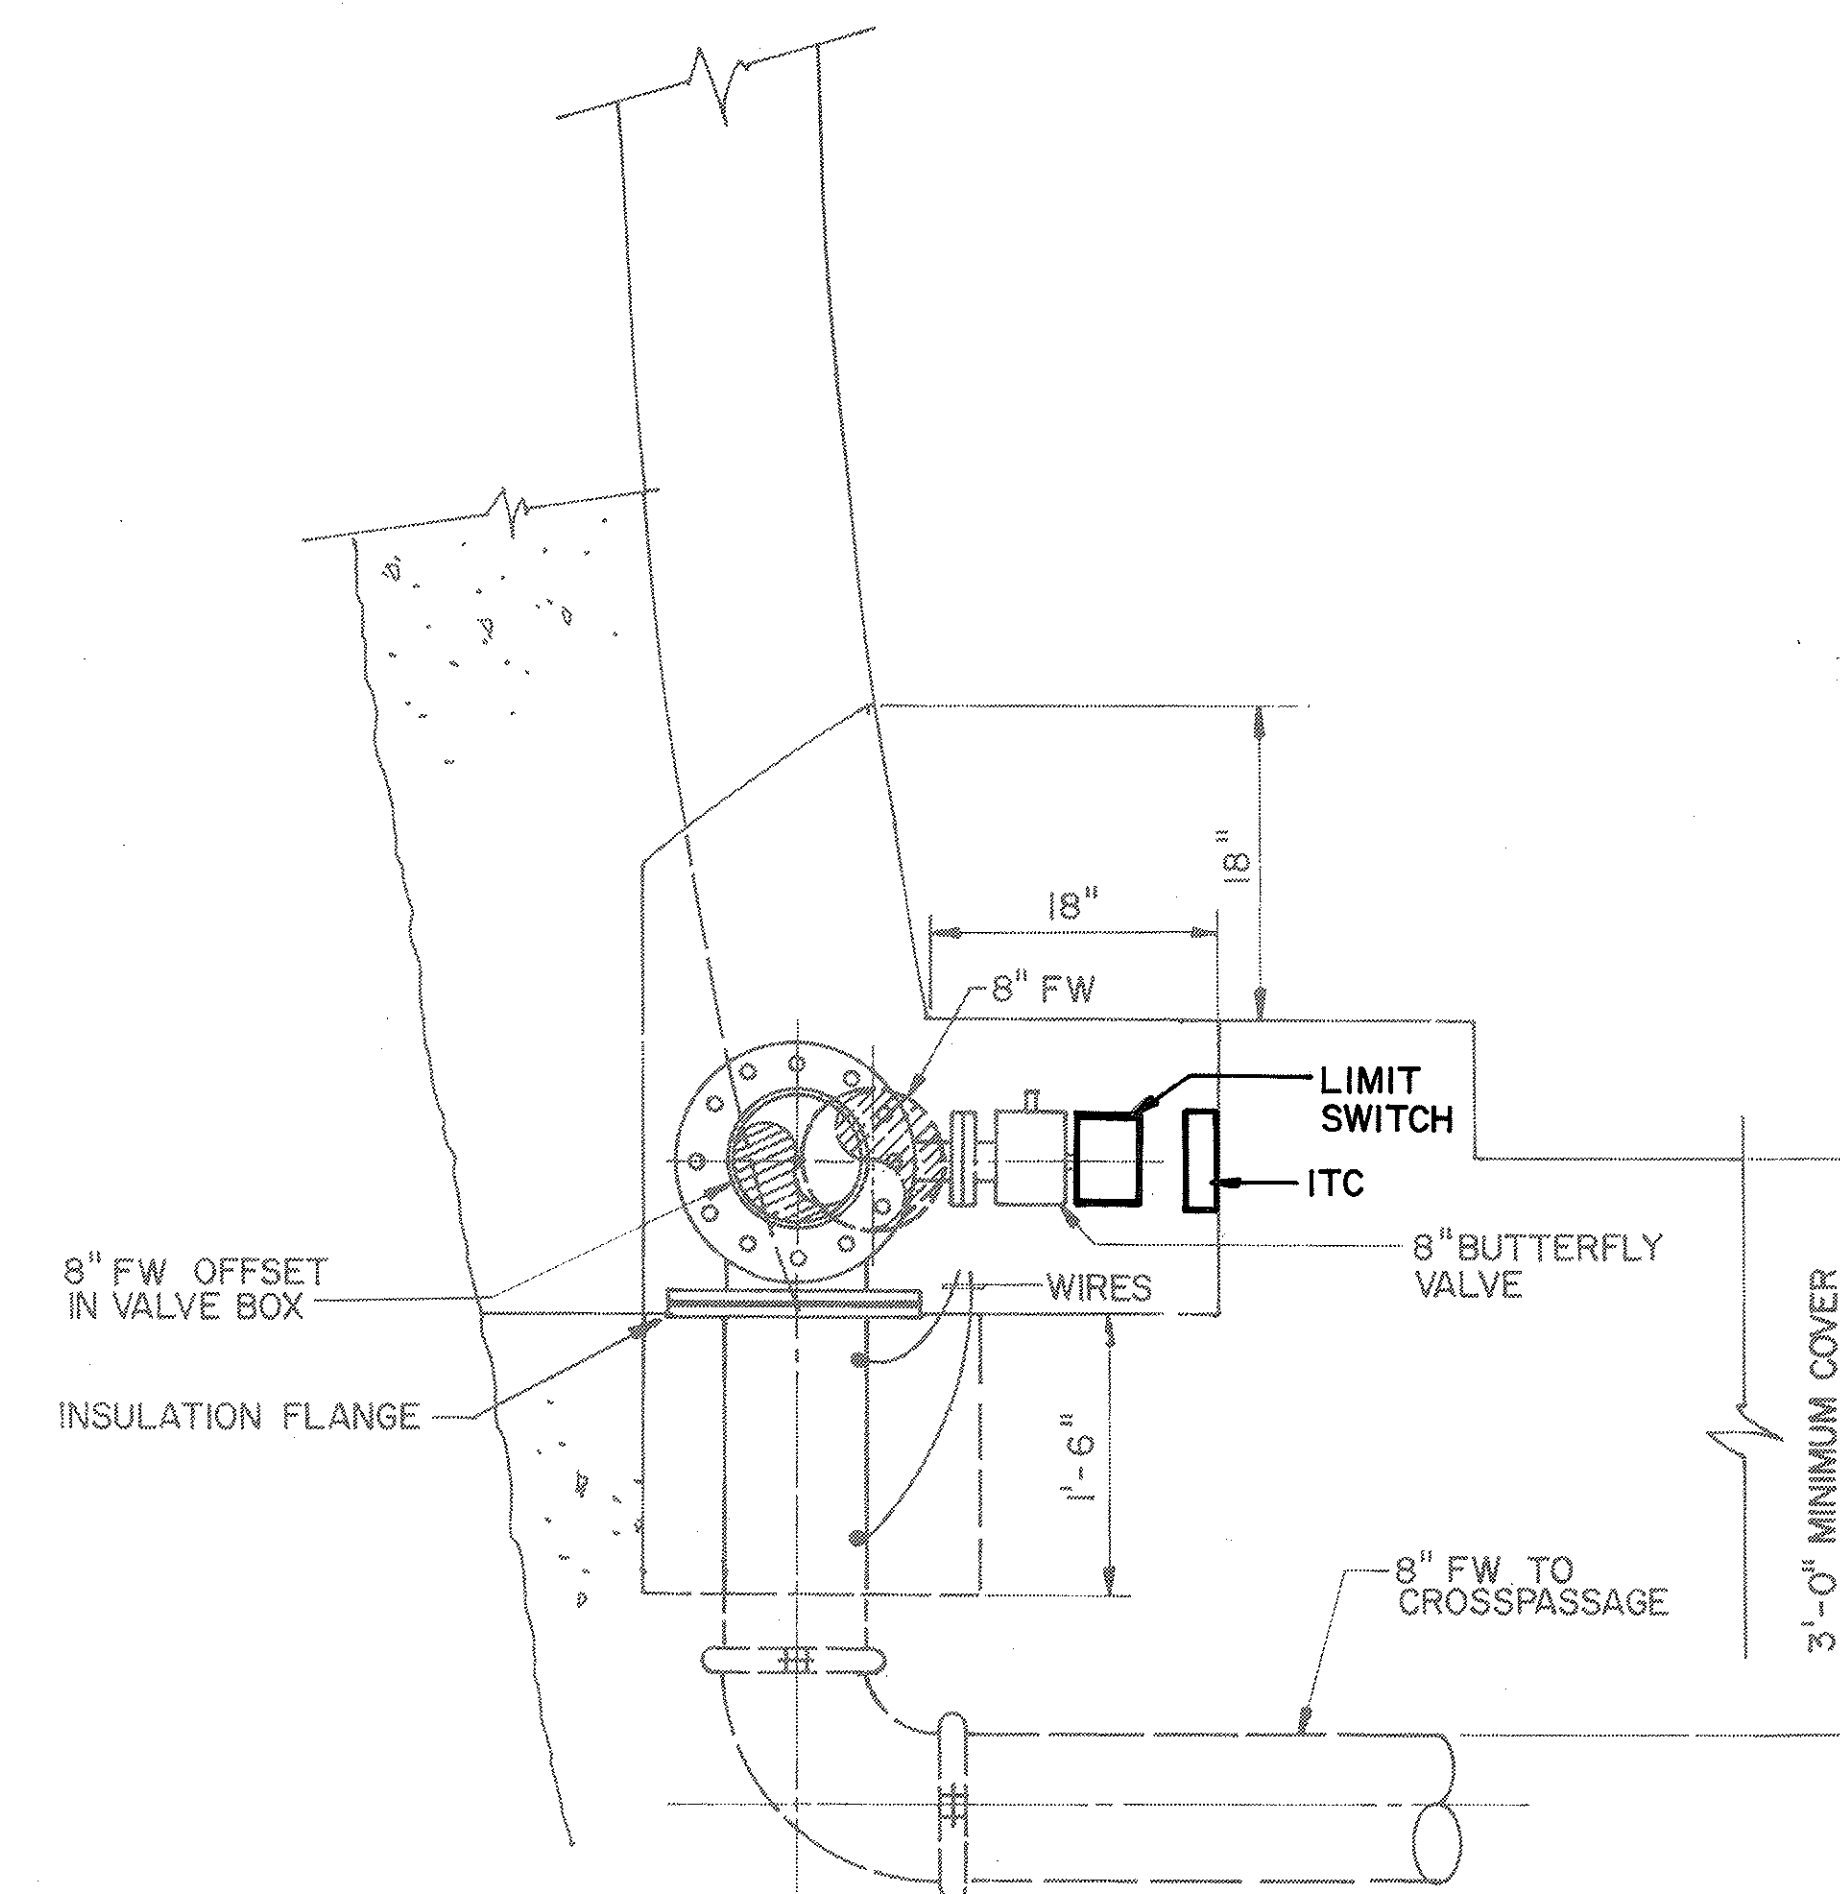

SECTION

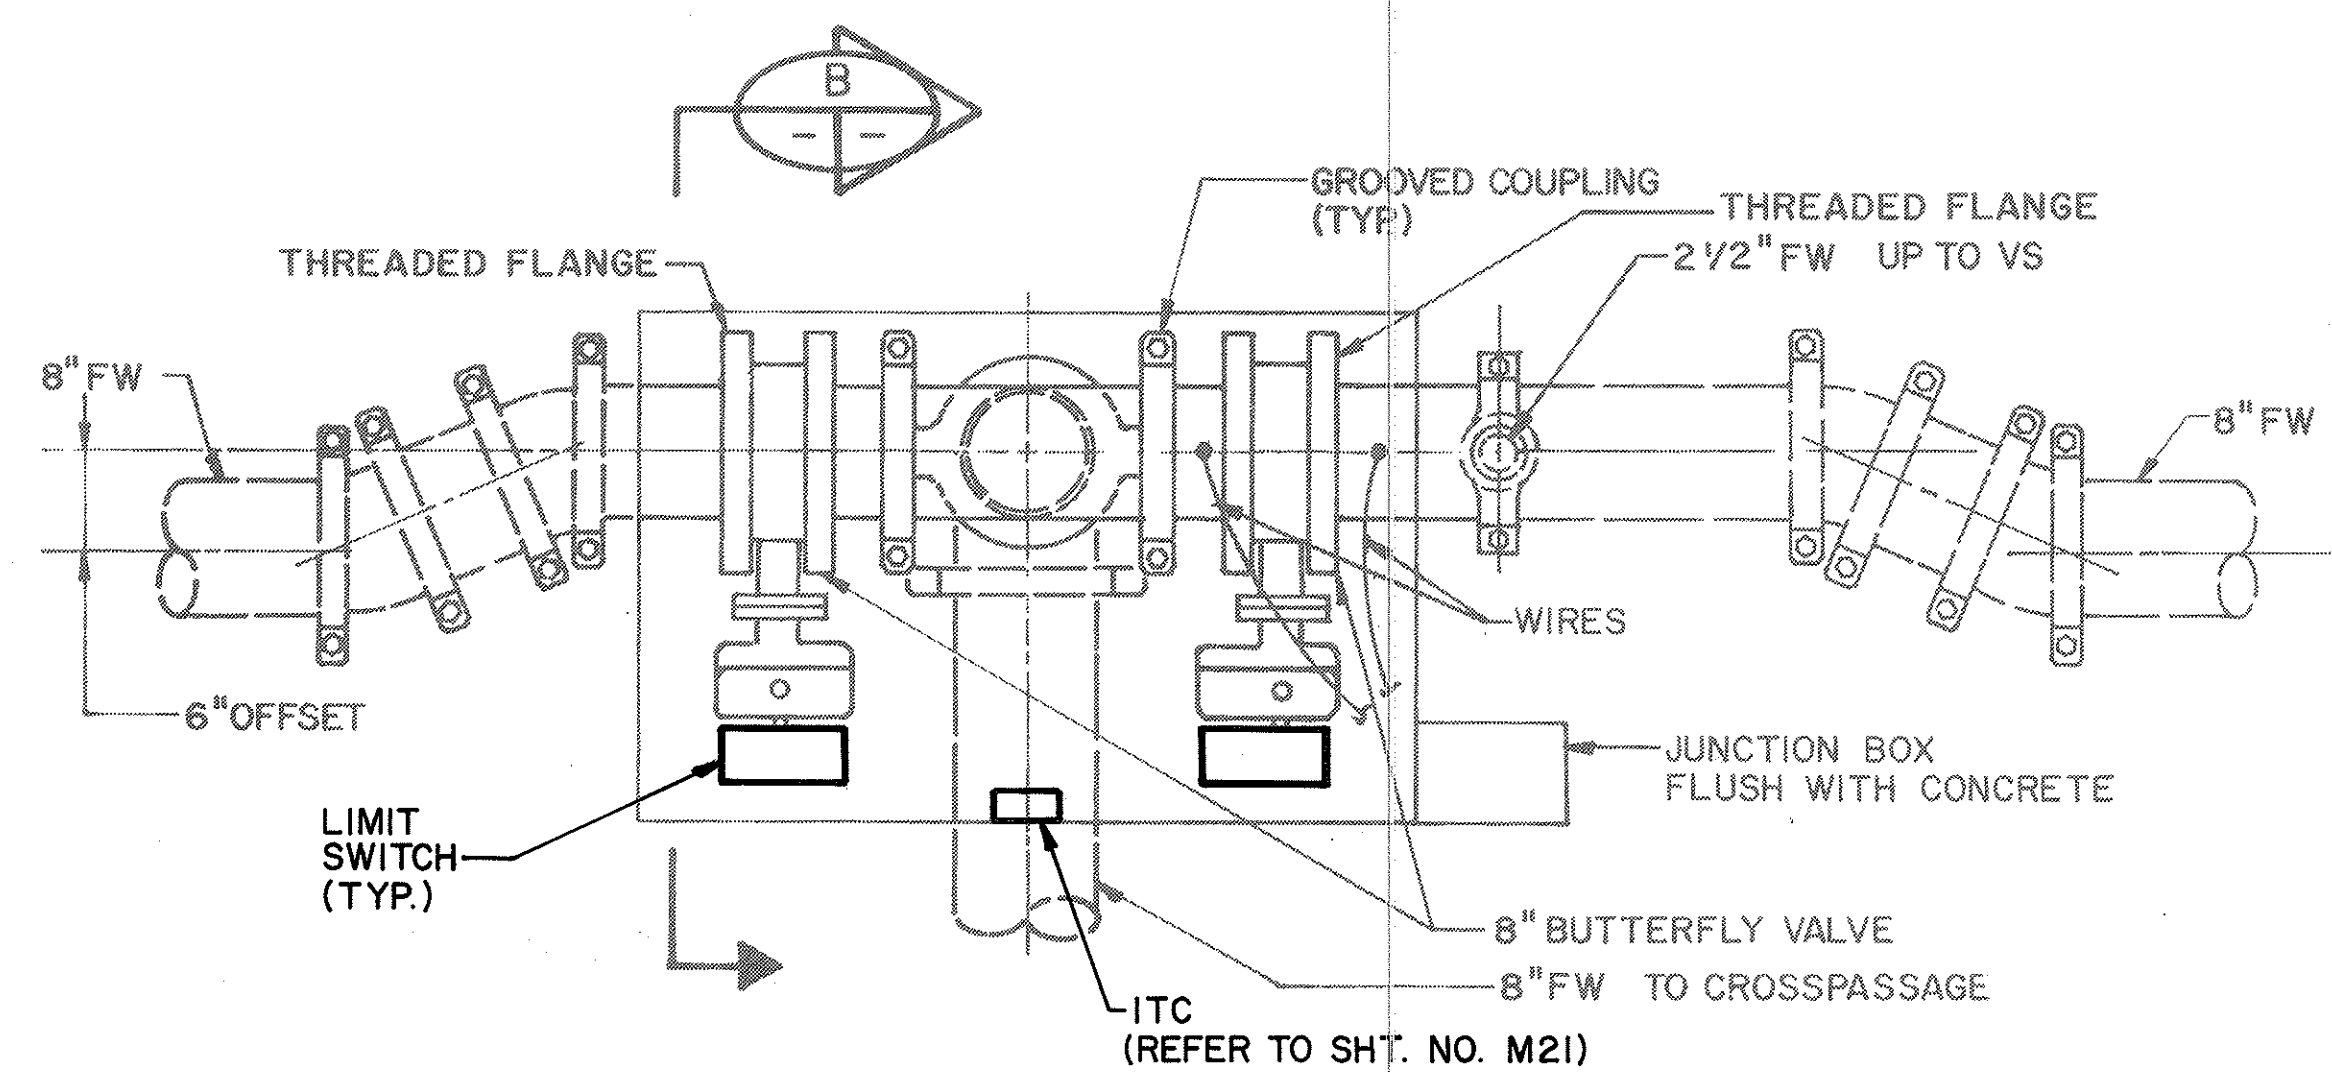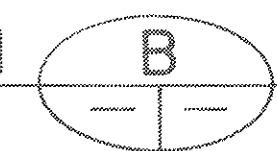

VALVE BOX DETAIL



DATE	REVISION

STATE OF HAWAII
 DEPARTMENT OF TRANSPORTATION
 HIGHWAYS DIVISION


FIRE PROTECTION -
SECTIONS AND DETAILS

HALAWA TUNNELS

INTERSTATE ROUTE H-3
 F.A.I. PROJ. NO. I-H3-1(66)

SCALE: NONE
DATE: APR 1992


SHEET NO. MT2 OF 3 SHEETS

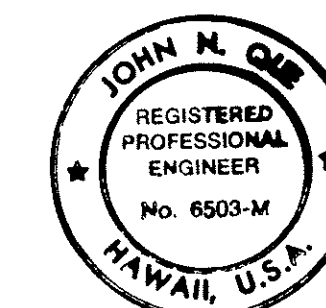


THIS WORK WAS PREPARED BY ME
OR UNDER MY SUPERVISION

John W. Doe


FED. ROAD DIST. NO.	STATE	FED. AID PROJ. NO.	FISCAL YEAR	SHEET NO.	TOTAL SHEETS
HAWAII	HAW.	I-H3-1(66)	1992	76	440

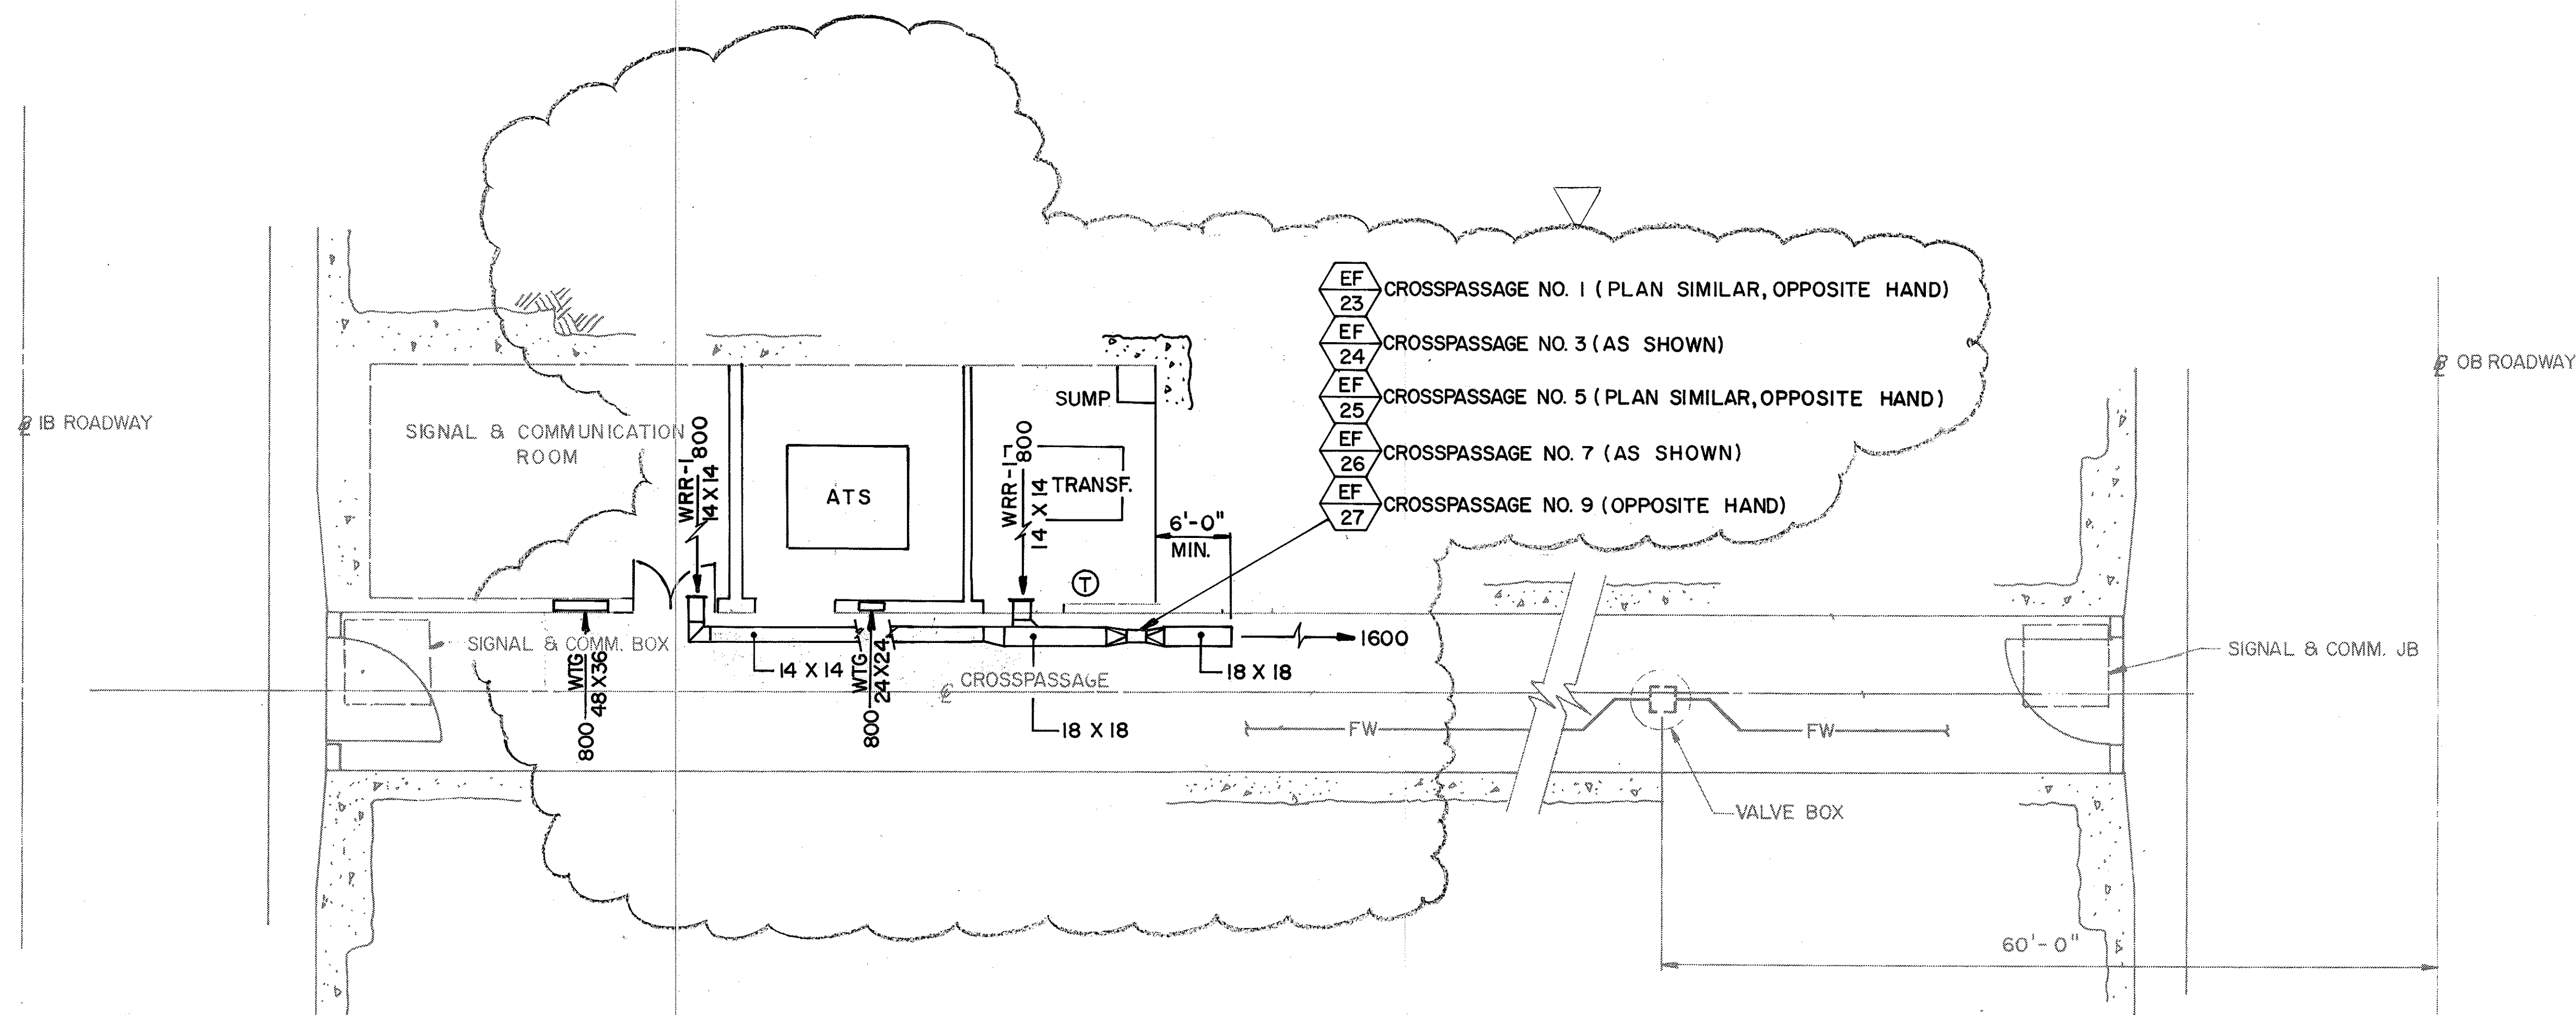



CROSSPASSAGE PLAN
SCALE: 1/8" = 1'-0"

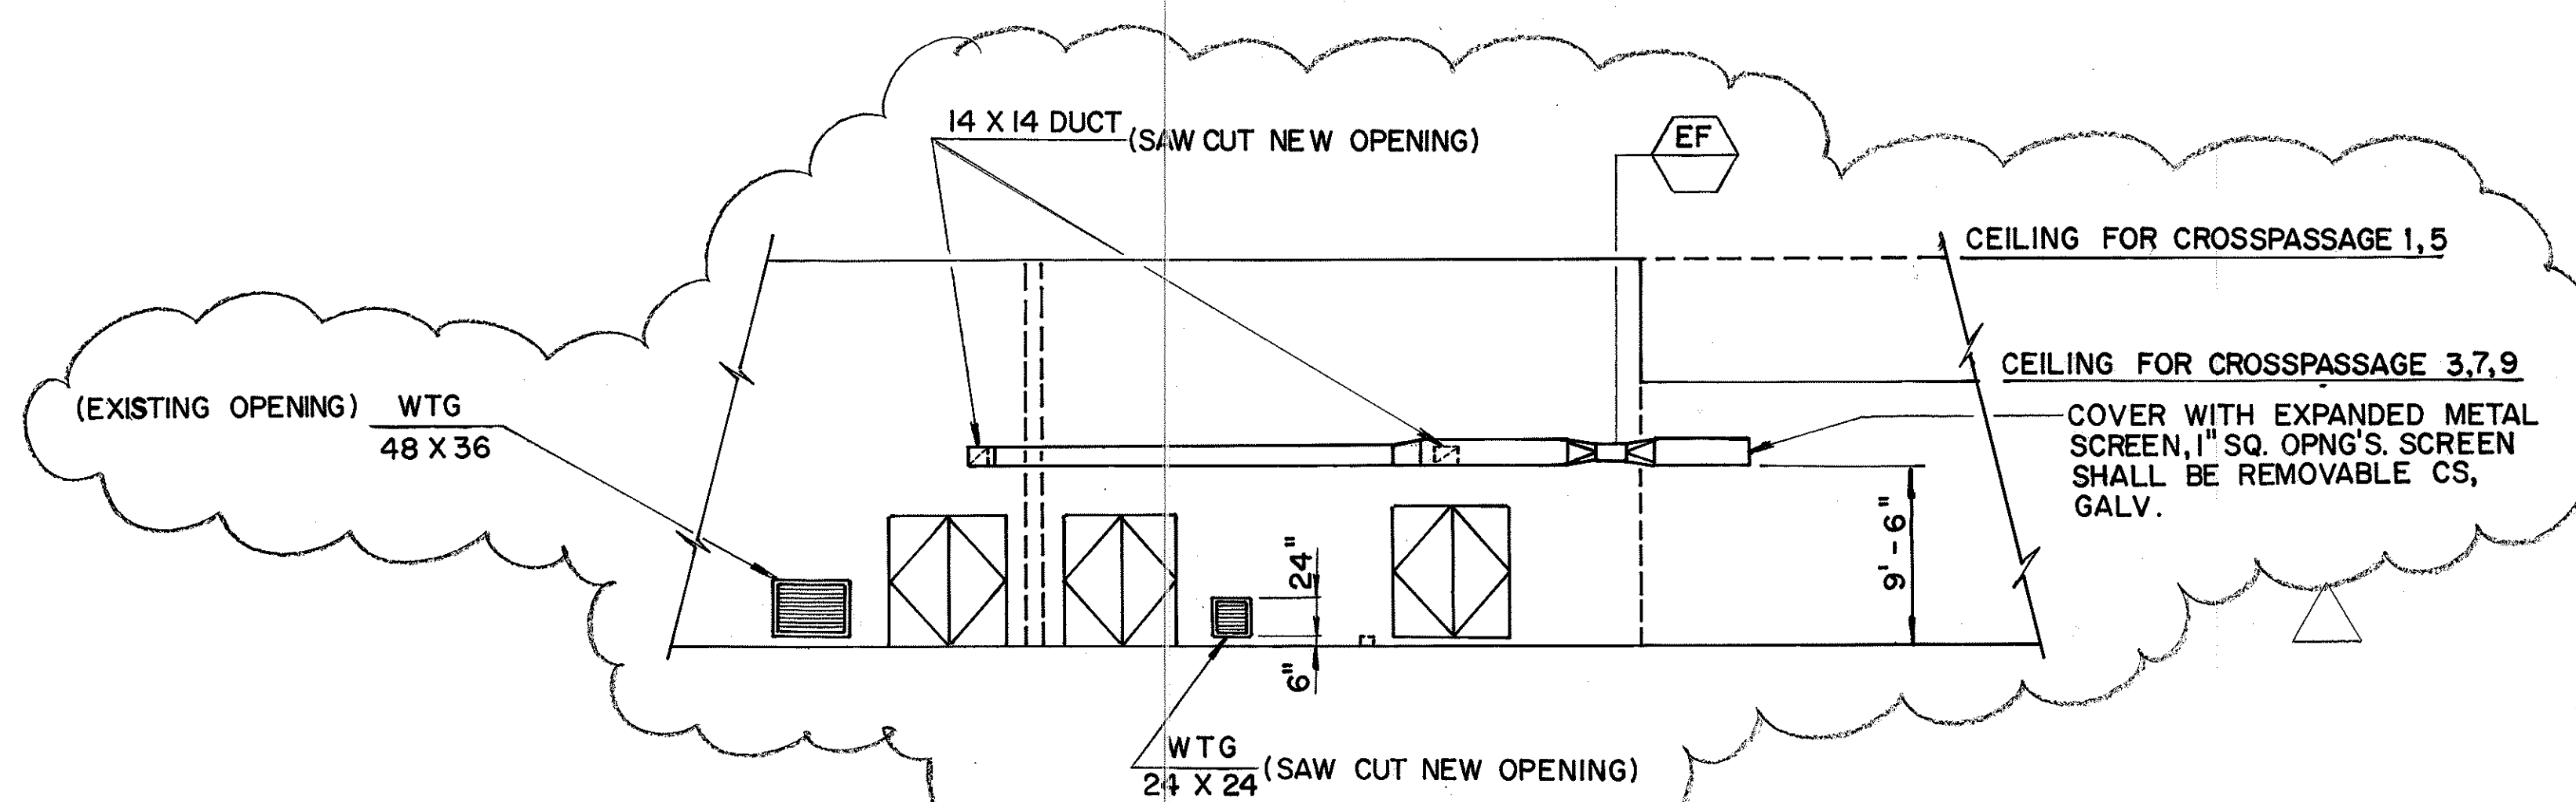

ELEVATION
SCALE: 1/8" = 1'-0"

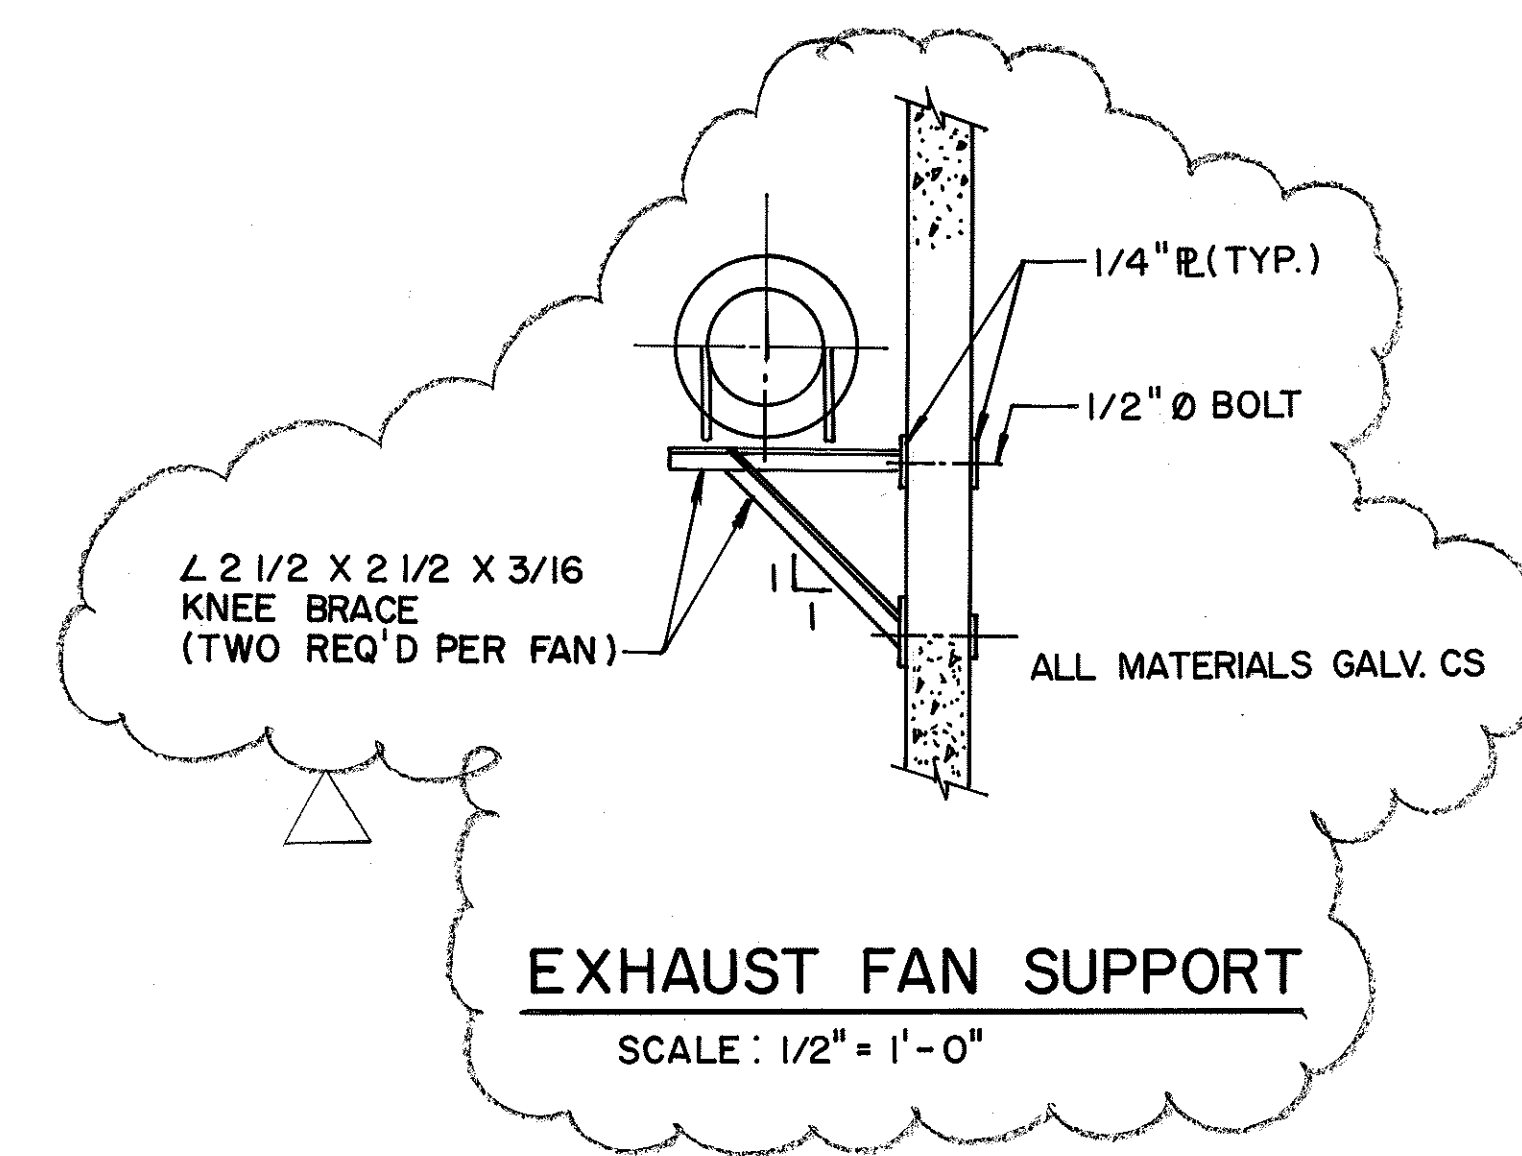


EXHAUST FAN SUPPORT
SCALE: 1/2" = 1'-0"

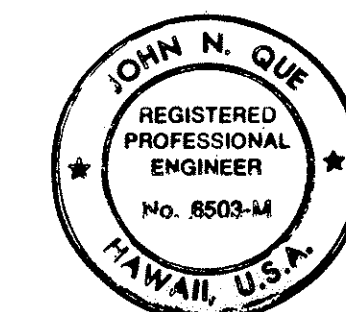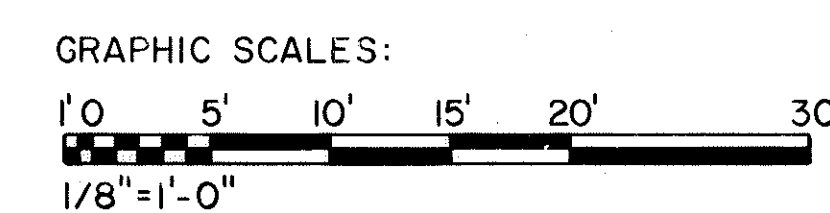


THIS WORK WAS PREPARED BY ME
OR UNDER MY SUPERVISION

3/4/94	REVISED PER DCN 66-037
DATE	REVISION
STATE OF HAWAII DEPARTMENT OF TRANSPORTATION HIGHWAYS DIVISION	
HVAC	
CROSSPASSAGE PLAN	
TUNNELS	
INTERSTATE ROUTE H-3	
F.A.I. PROJ. NO. I-H3-1(66)	
SCALE: AS NOTED	DATE:
SHEET MT3 OF 3 SHEETS	


FED. ROAD DIST. NO.	STATE	FED. AID PROJ. NO.	FISCAL YEAR	SHEET NO.	TOTAL SHEETS
HAWAII	HAW.	I - H3 - I(66)	1992	78	440

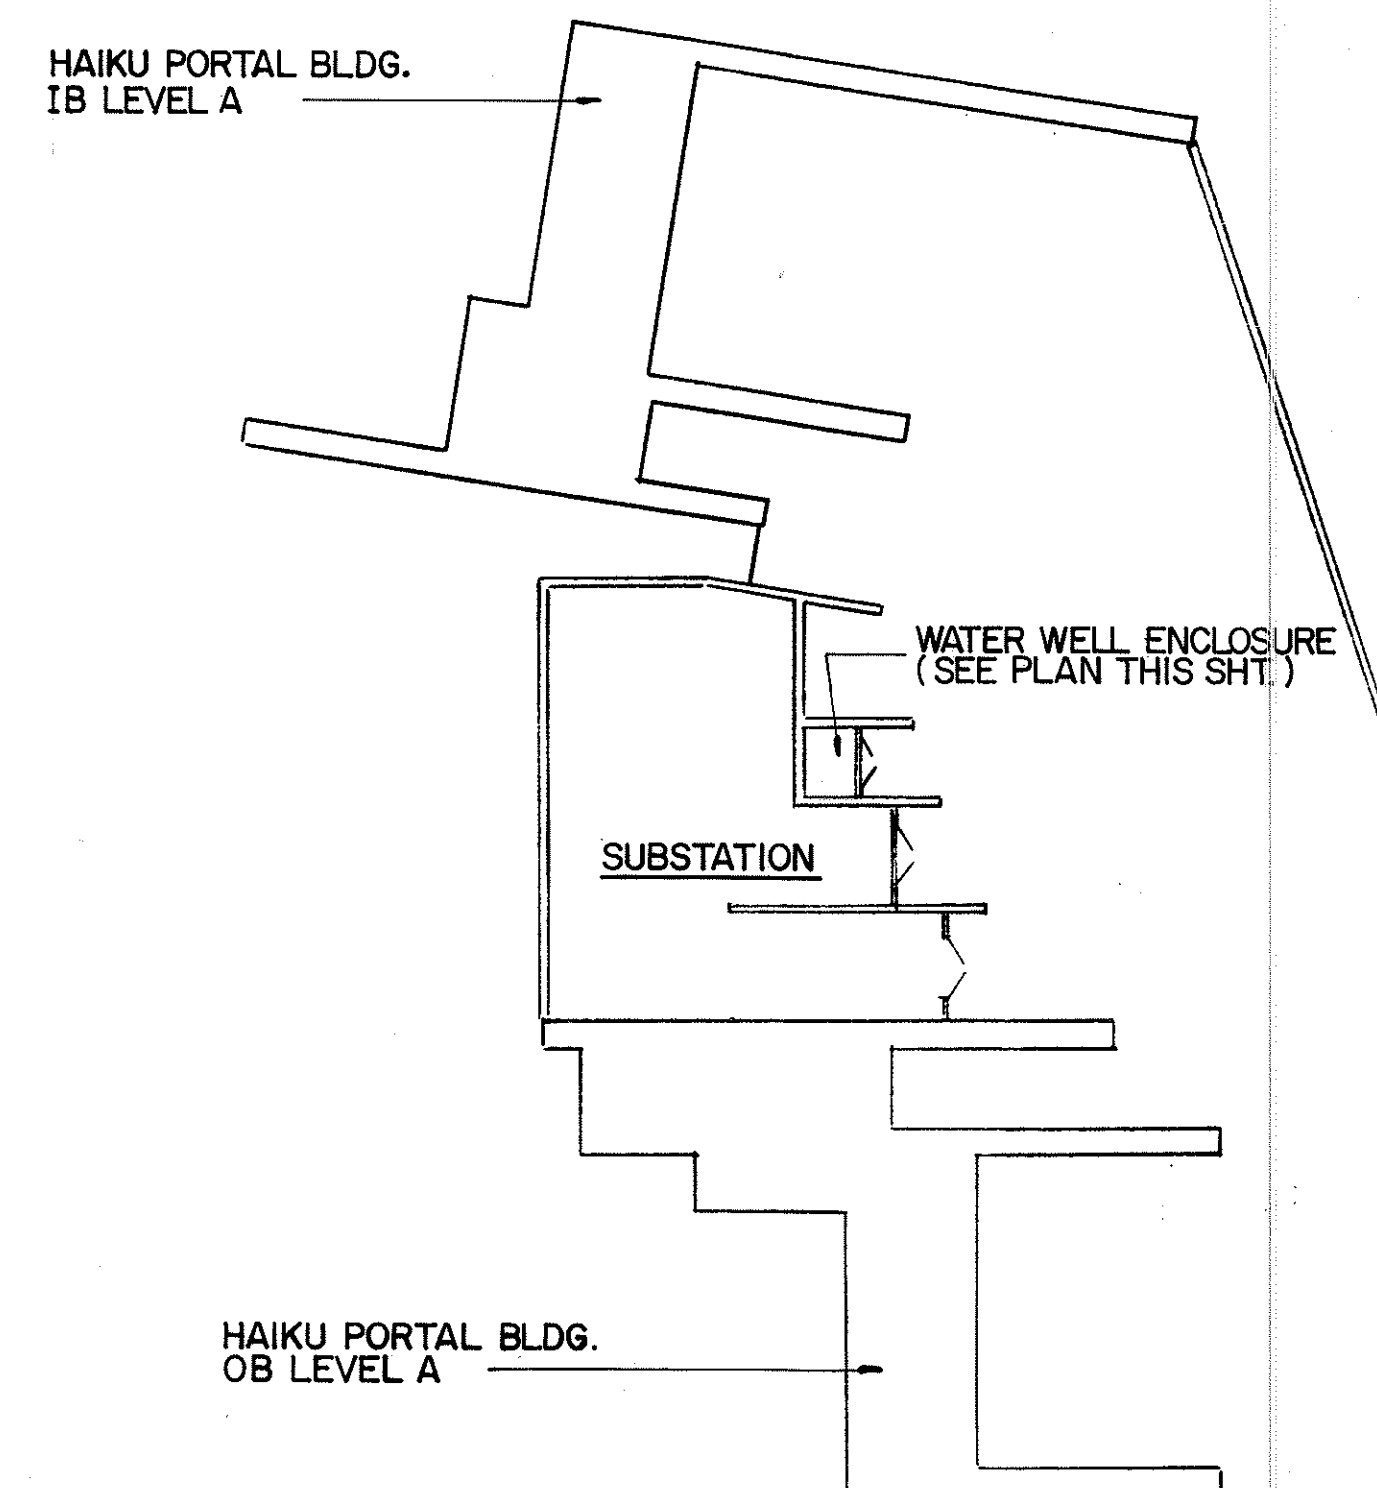


KEY PLAN
SCALE: 1" = 40'-0"

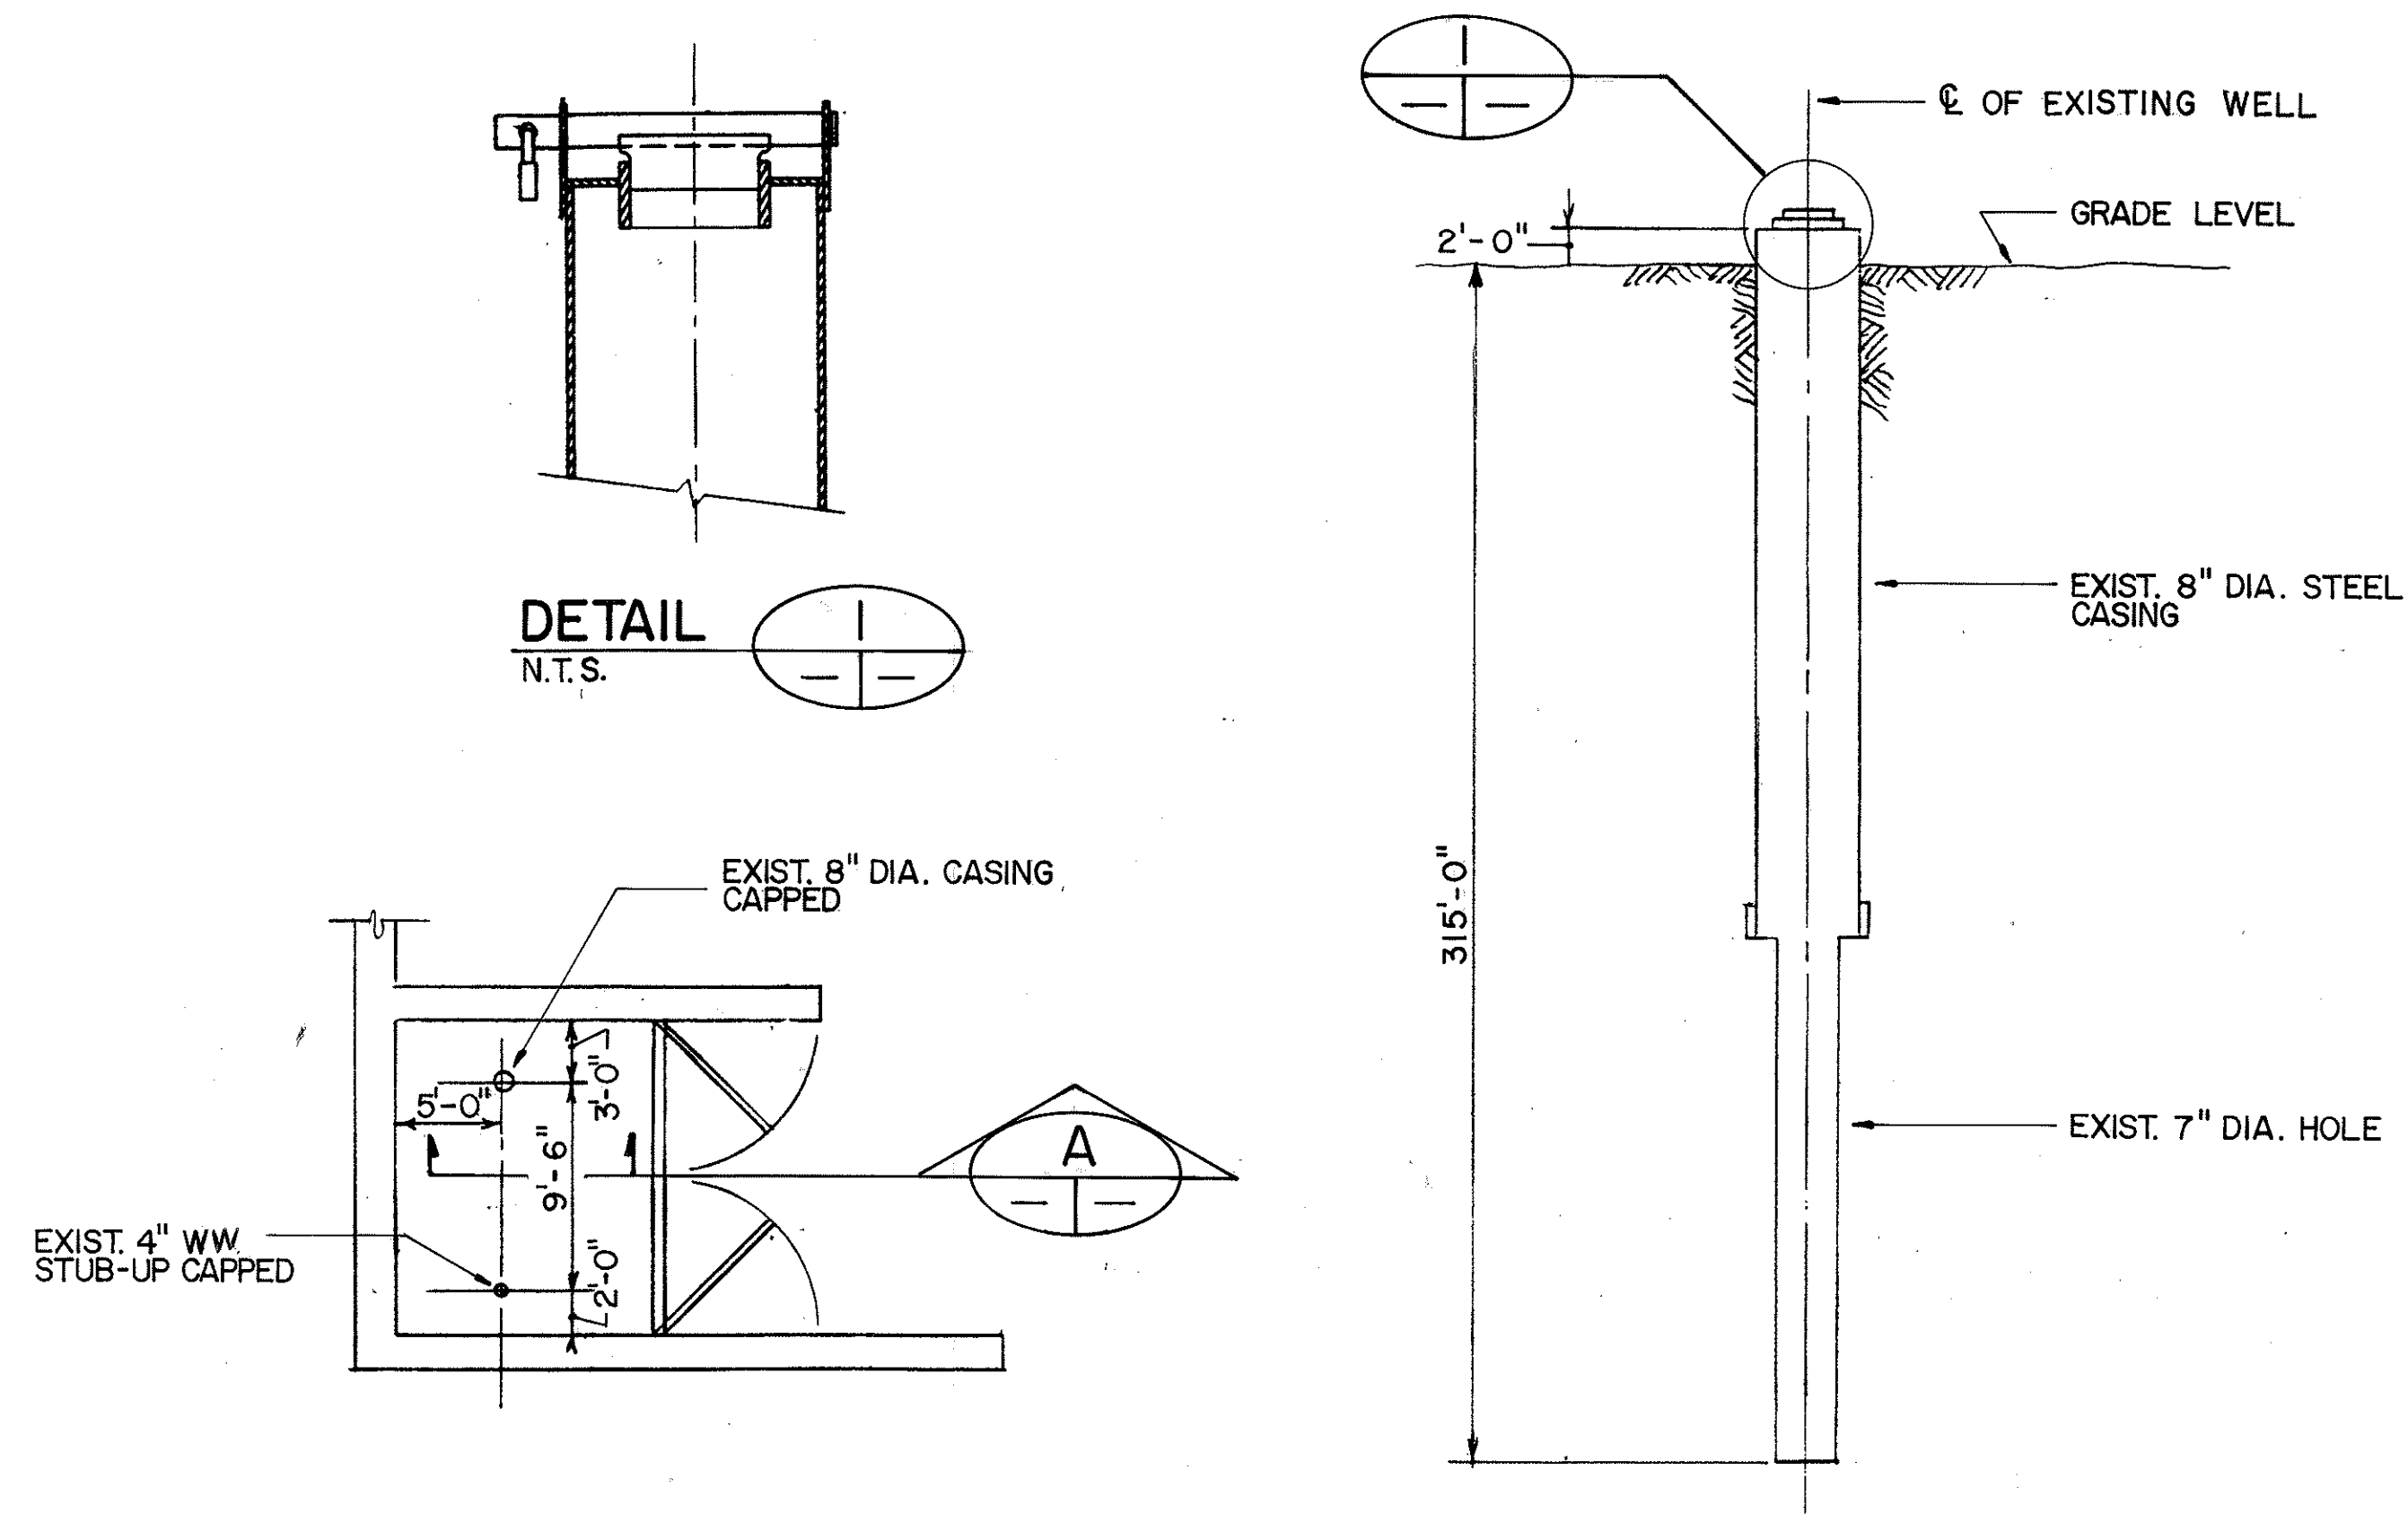

EXIST. WATER WELL ENCLOSURE PLAN
SCALE: 1/8" = 1' - 0"

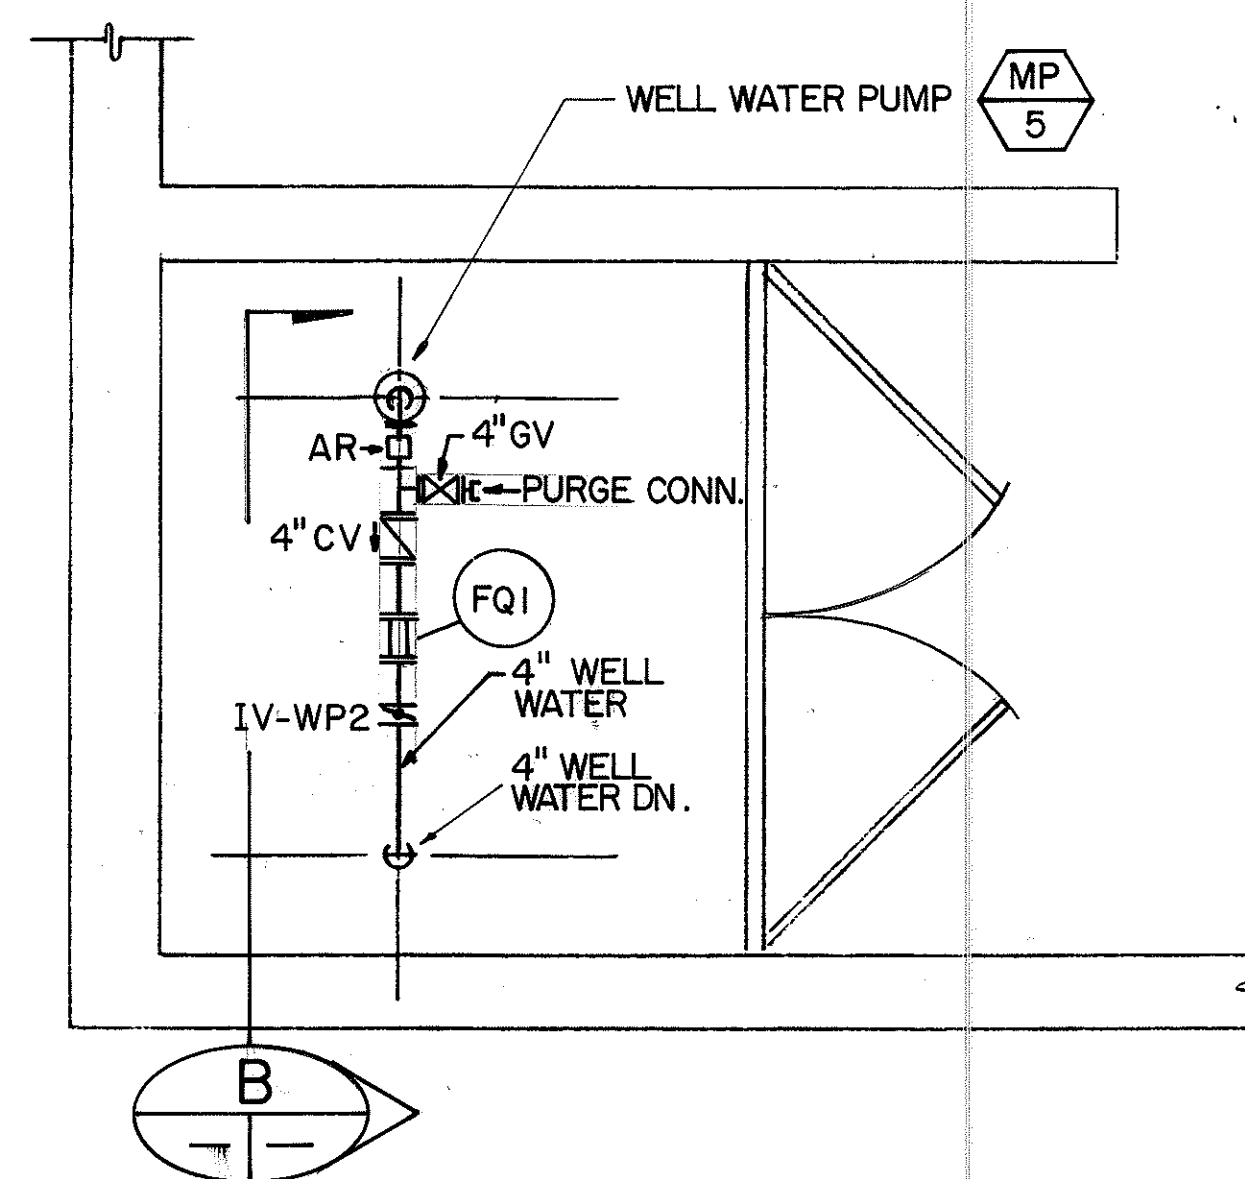

WELL WATER PUMP & PIPING PLAN
SCALE: 1/4" = 1'-0"

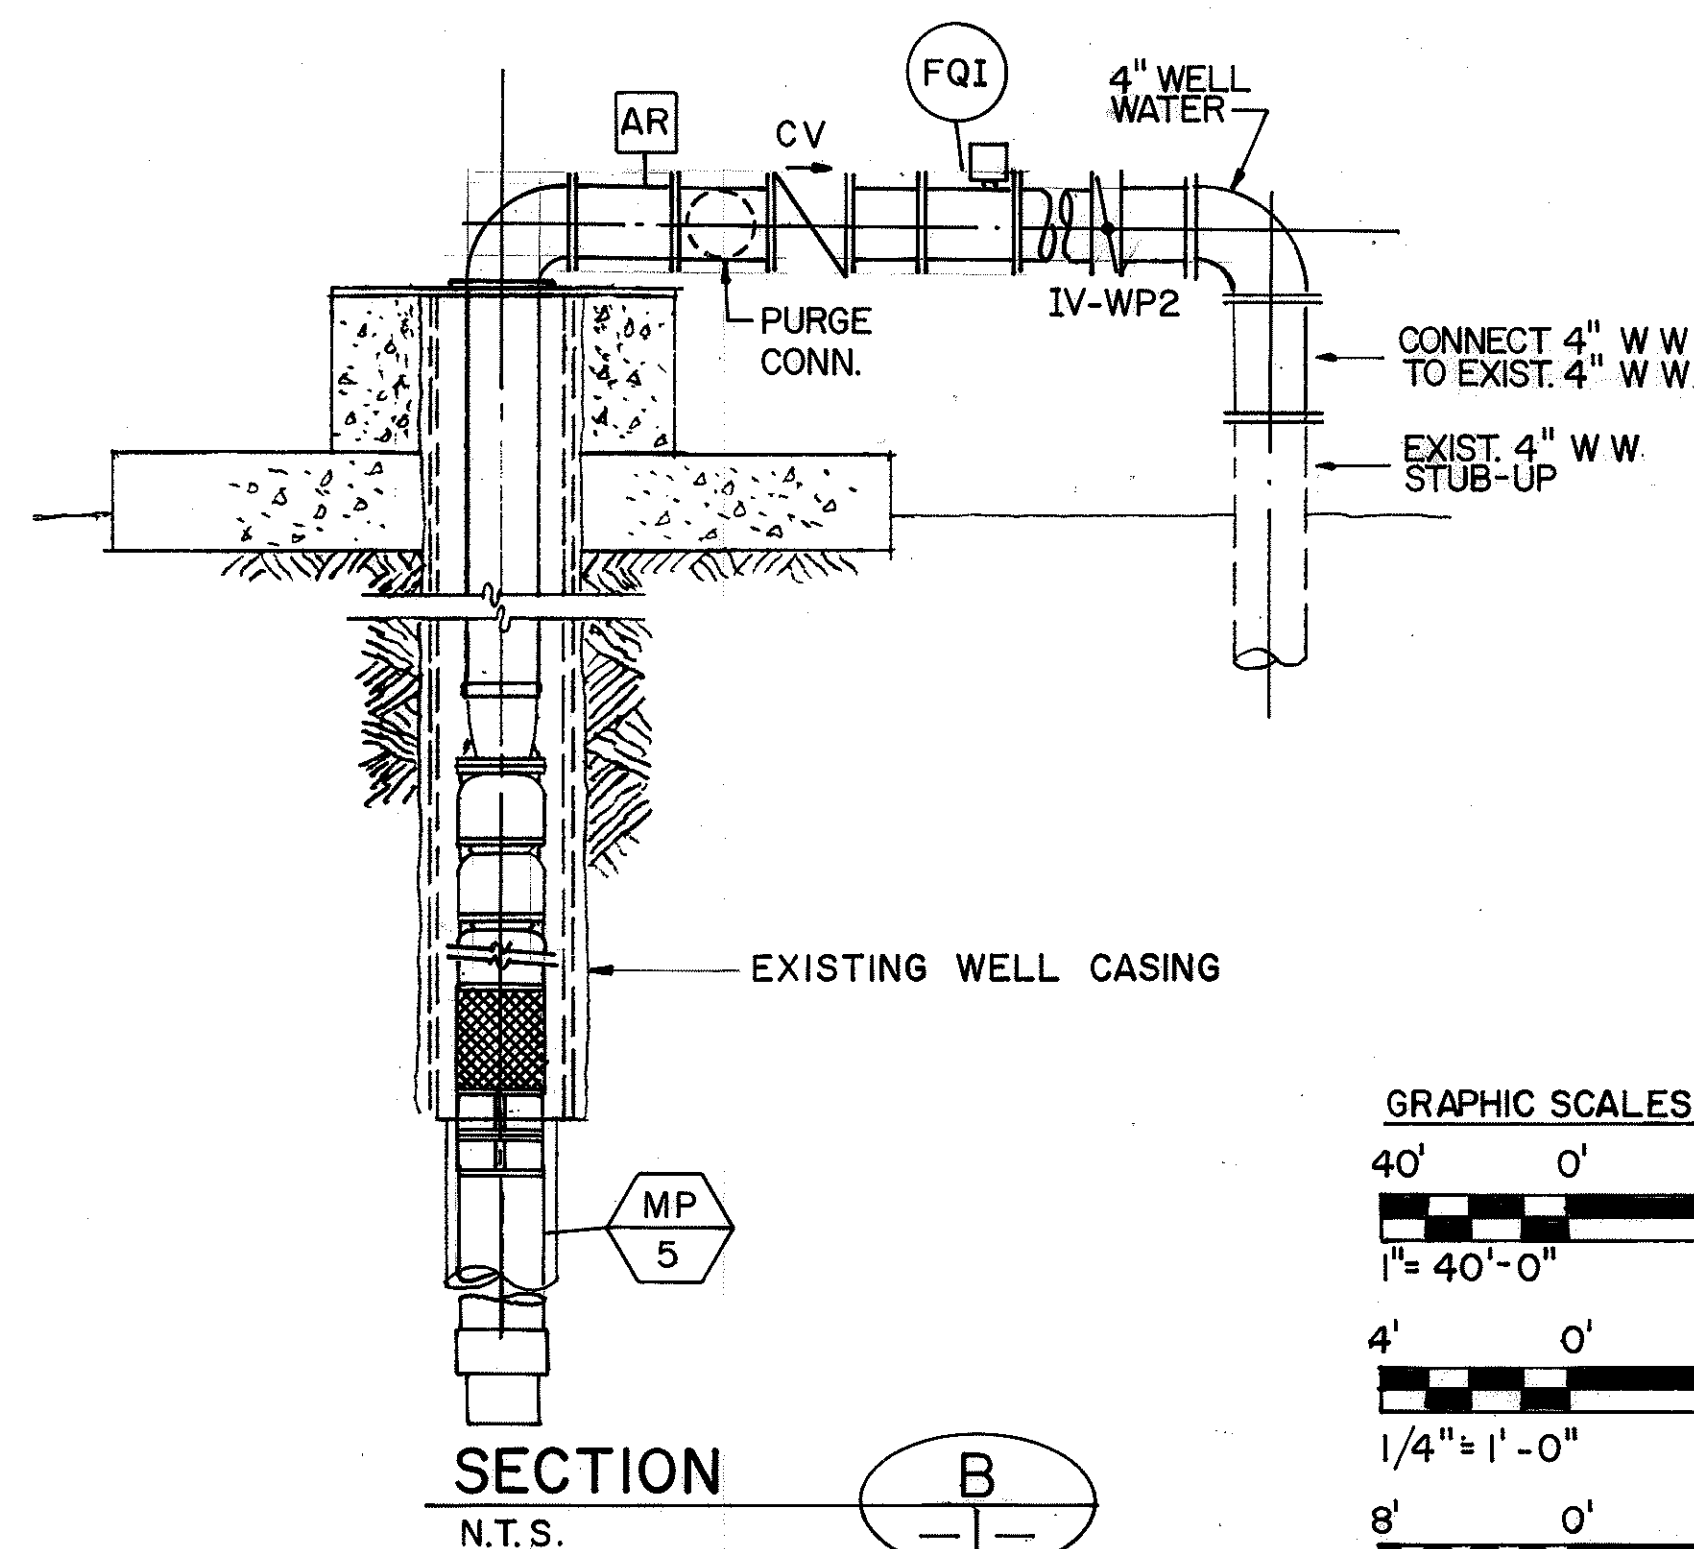

SECTION
N.T.S.

GRAPHIC SCALES

40' 0' 40' 80'

$1'' = 40' - 0''$

4' 0' 4' 8'

$1/4'' = 1' - 0''$

8' 0' 8' 16'

$1/8'' = 1' - 0''$



THIS WORK WAS PREPARED BY ME
OR UNDER MY SUPERVISION

DATE	REVISION

STATE OF HAWAII
 DEPARTMENT OF TRANSPORTATION
 HIGHWAYS DIVISION

PLUMBING - WELL WATER PUMP

PLAN & SECTION

HAIKU APPROACH

INTERSTATE ROUTE H-3

F.A.I. PROJ. NO. I-H3-1 (66)


SCALE : AS NOTED

DATE : APR 1992

SHEET NO. MB2 OF 2 SHEETS




FED. ROAD DIST. NO.	STATE	FED. AID PROJ. NO.	FISCAL YEAR	SHEET NO.	TOTAL SHEETS
HAWAII	HAW.	I-H3-1(66)	1992	79	440

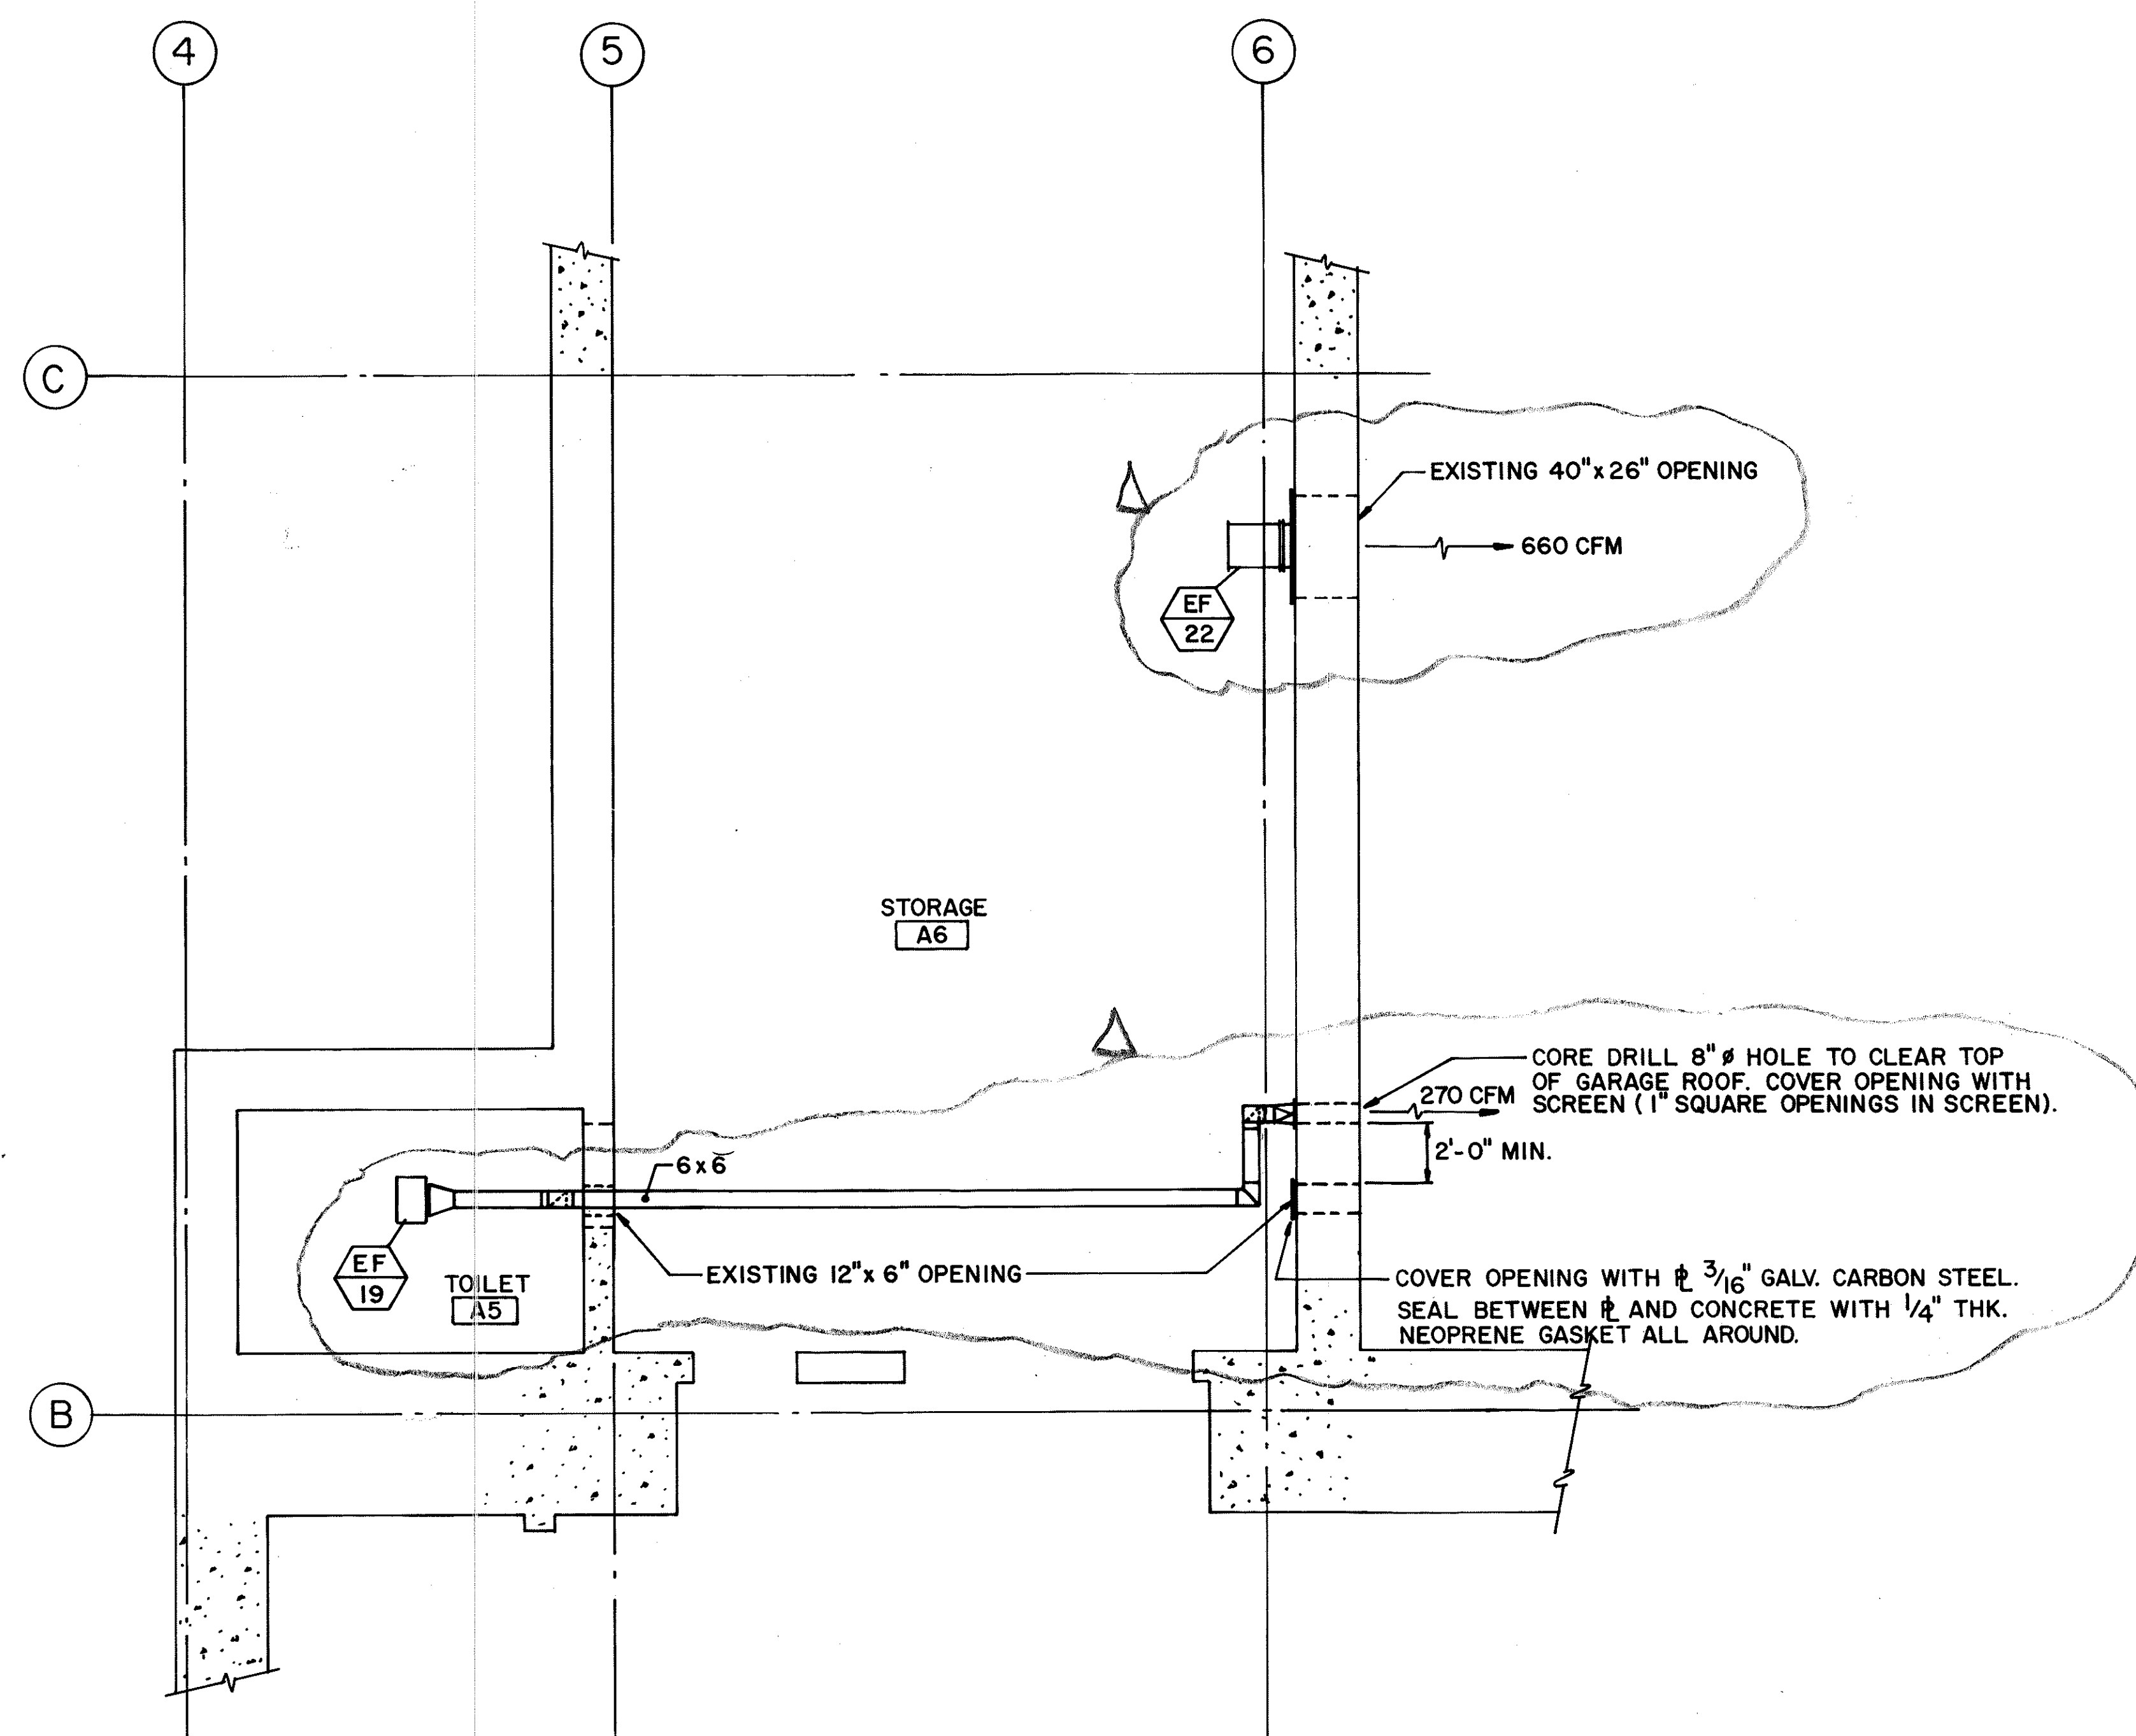

LEVEL A PARTIAL PLAN

FOR DETAIL AS-BUILT INFORMATION
REFER TO CONSTRUCTION SUBMITTALS

5/11/94	ADDED EF-19 AND RELOCATED EF-22 PER DCN 66-042
---------	--

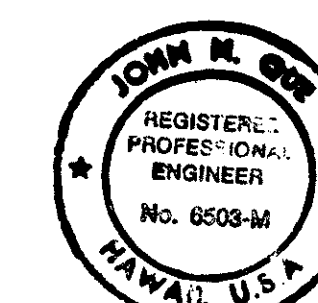

THIS WORK WAS PREPARED BY ME
OR UNDER MY SUPERVISION


GRAPHIC SCALE
1" = 0' 1' 2' 3' 4' 5'
1/4" = 1'-0"

STATE OF HAWAII
DEPARTMENT OF TRANSPORTATION
HIGHWAYS DIVISION
**HVAC - LEVEL A
PARTIAL PLAN**
HAIKU PORTAL BUILDING - 1B
INTERSTATE ROUTE H-3
F.A.I. PROJ. NO. I-H3-1(66)



SCALE: 1/4"=1'-0" DATE: APR 1992
SHEET NO. MM I OF 7 SHEETS

ORIGINAL PLAN	SURVEY PLOTTED BY	DATE
NOTE BOOK	DRAWN BY	3/22/89
	TRACED BY	3/4/89
	QUANTITIES BY	
	CHECKED BY	6/12/90

FED. ROAD DIST. NO.	STATE	FED. AID PROJ. NO.	FISCAL YEAR	SHEET NO.	TOTAL SHEETS
HAWAII	HAW.	I-H3-1(66)	1992	80	440

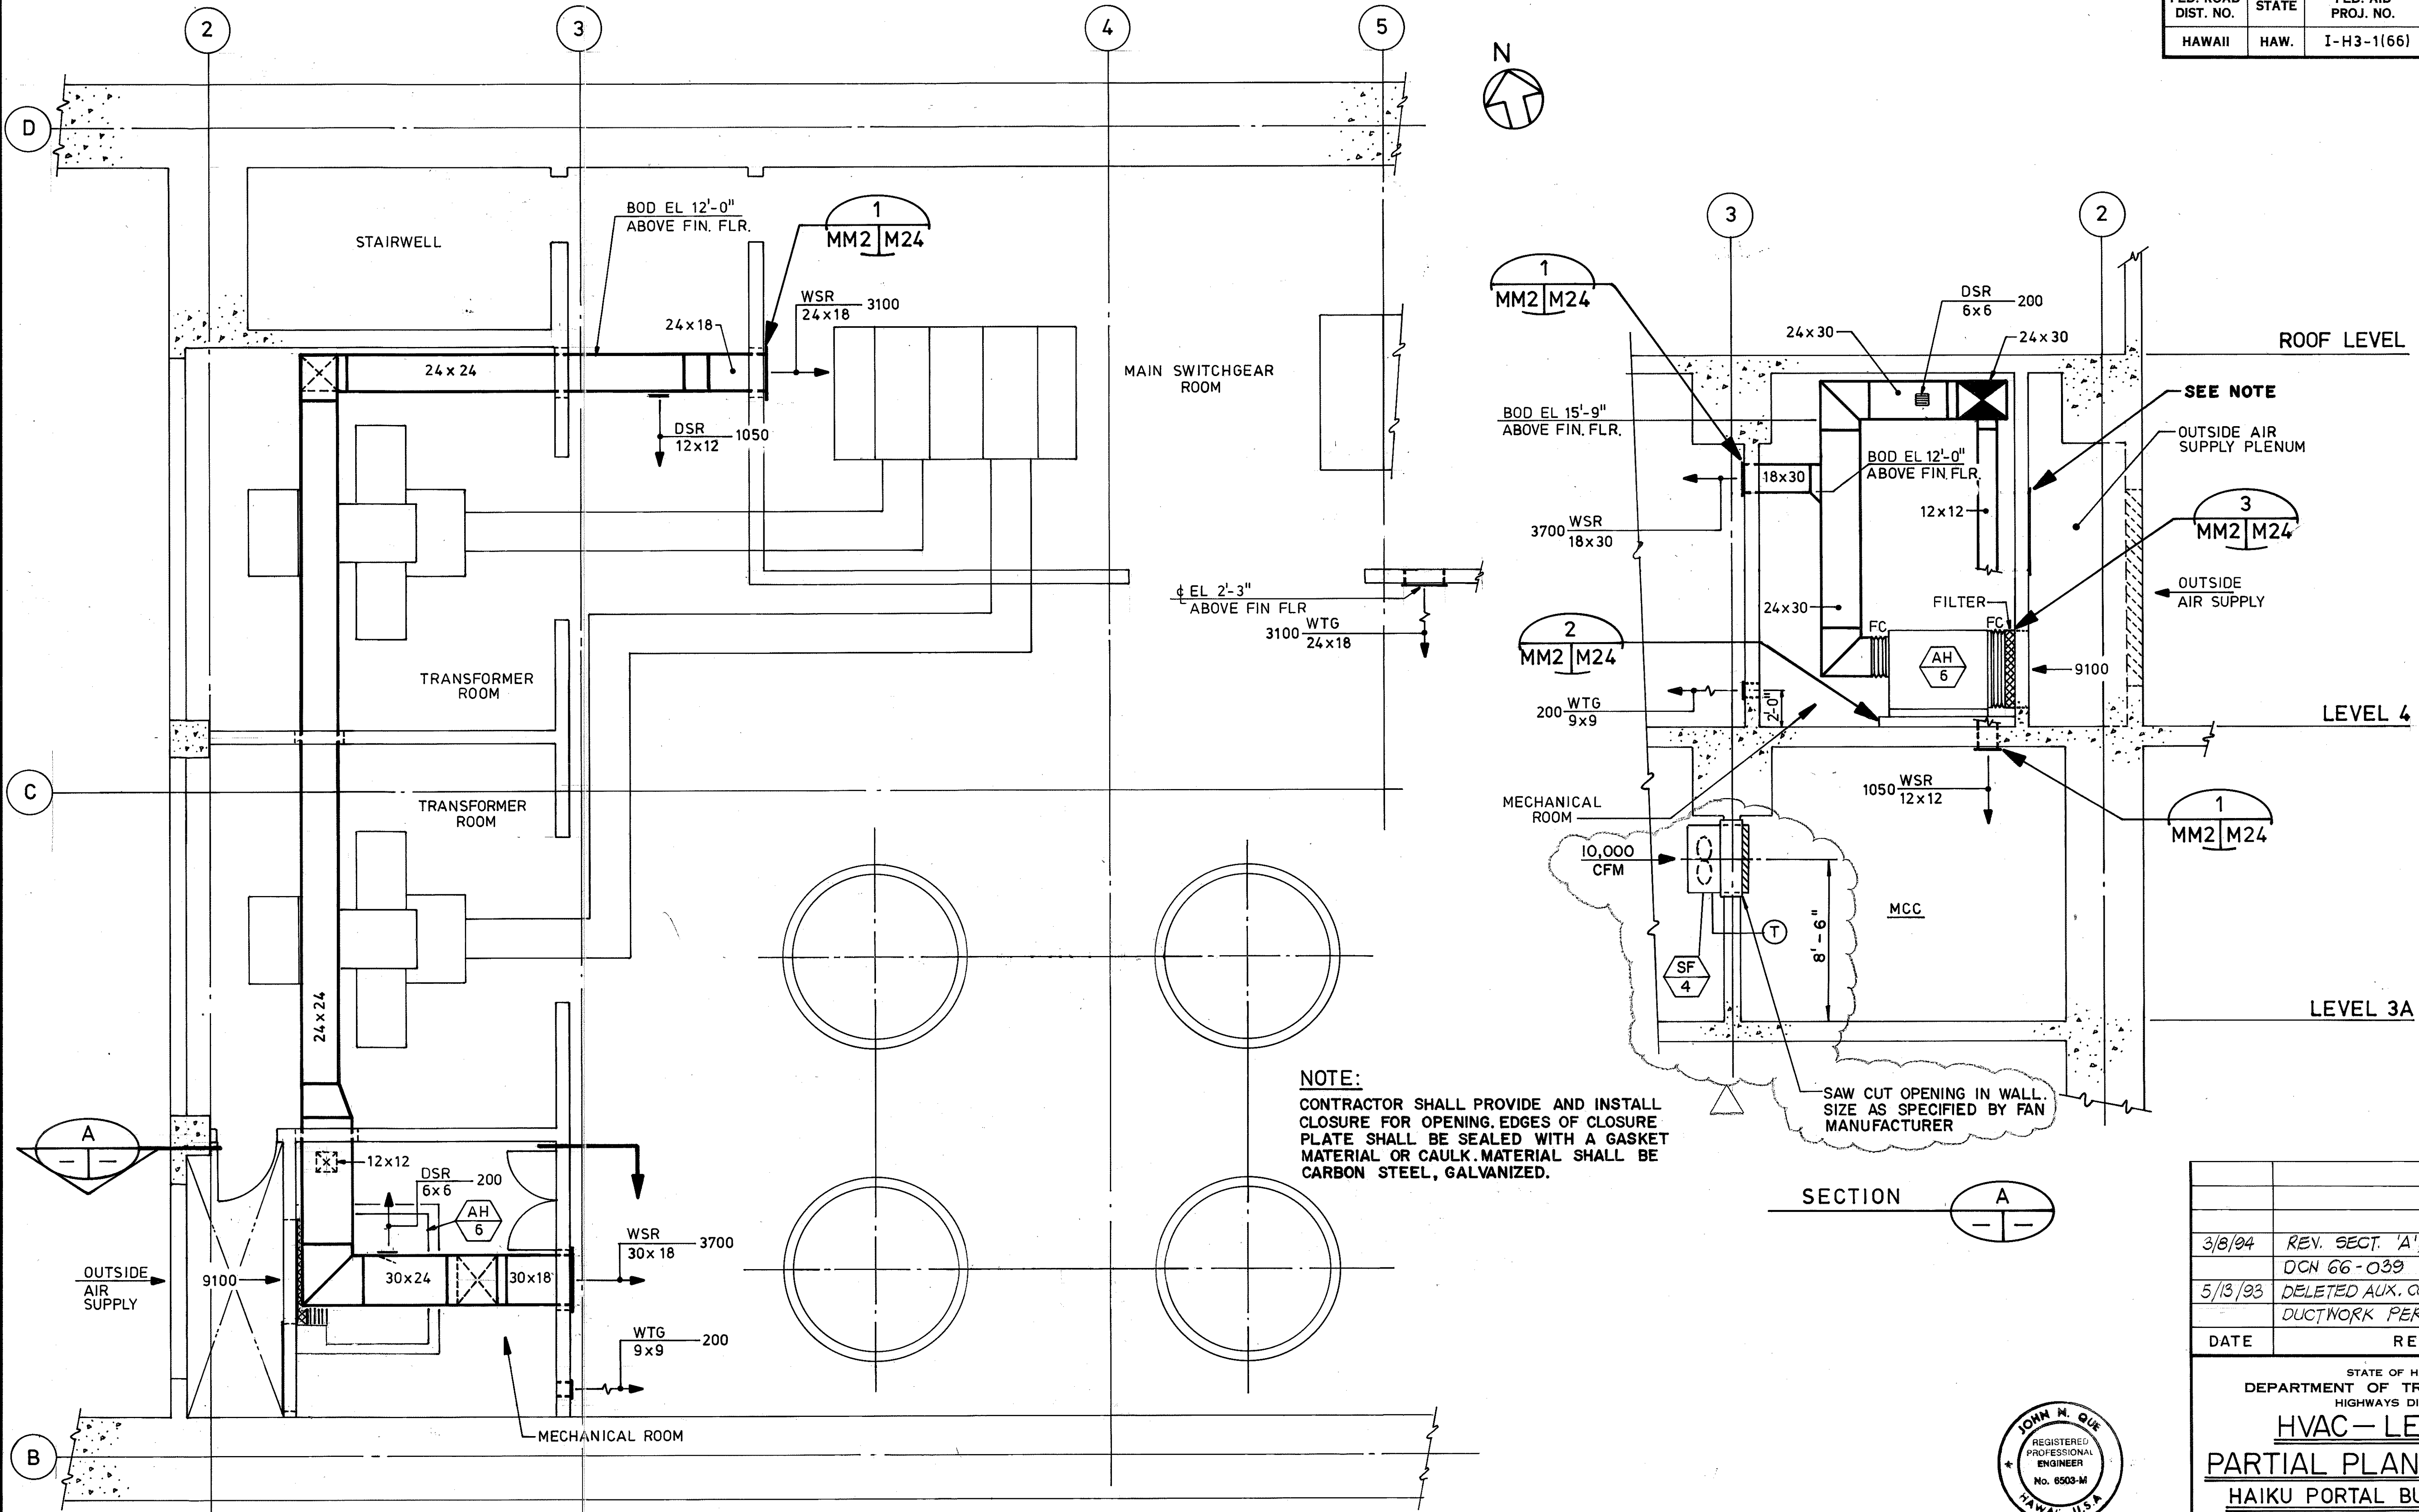

ORIGINAL PLAN	DATE
SURVEY PLOTTED BY	9/21/89
DRAWN BY	D. E. DRYDEN
TRACED BY	9/15/89
NOTED BY	D. E. DRYDEN
CHECKED BY	J. N. QUE
DATE	6/05/90

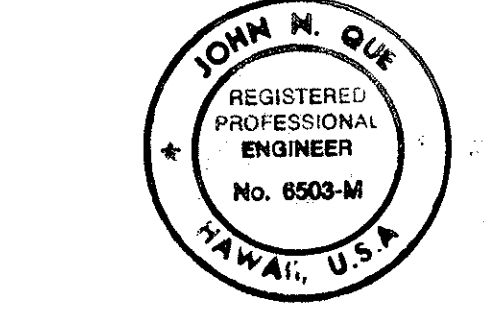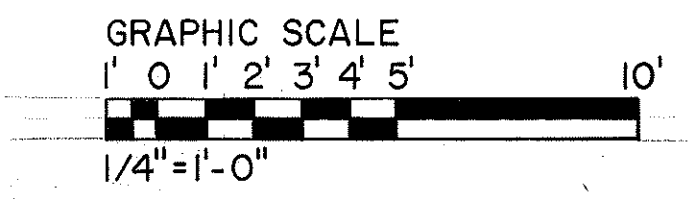


THIS WORK WAS PREPARED BY ME OR UNDER MY SUPERVISION


John M. Que

DATE	REVISION
3/8/94	REV. SECT. 'A', ADDED SF PER DCN 66-039
5/13/93	DELETED AUX. COOLING FANS & ASSOC. DUCTWORK PER DCN 66-004
STATE OF HAWAII DEPARTMENT OF TRANSPORTATION HIGHWAYS DIVISION HVAC—LEVEL 4 PARTIAL PLAN & SECTION HAIKU PORTAL BUILDING—IB INTERSTATE ROUTE H-3 F.A.I. PROJ. NO. I-H3-1(66) SCALE: 1/4"=1'-0" DATE: APR 1992 SHEET NO. MM2 OF 7 SHEETS	

FED. ROAD DIST. NO.	STATE	FED. AID PROJ. NO.	FISCAL YEAR	SHEET NO.	TOTAL SHEETS
HAWAII	HAW.	I-H3-1(66)	1992	81	440

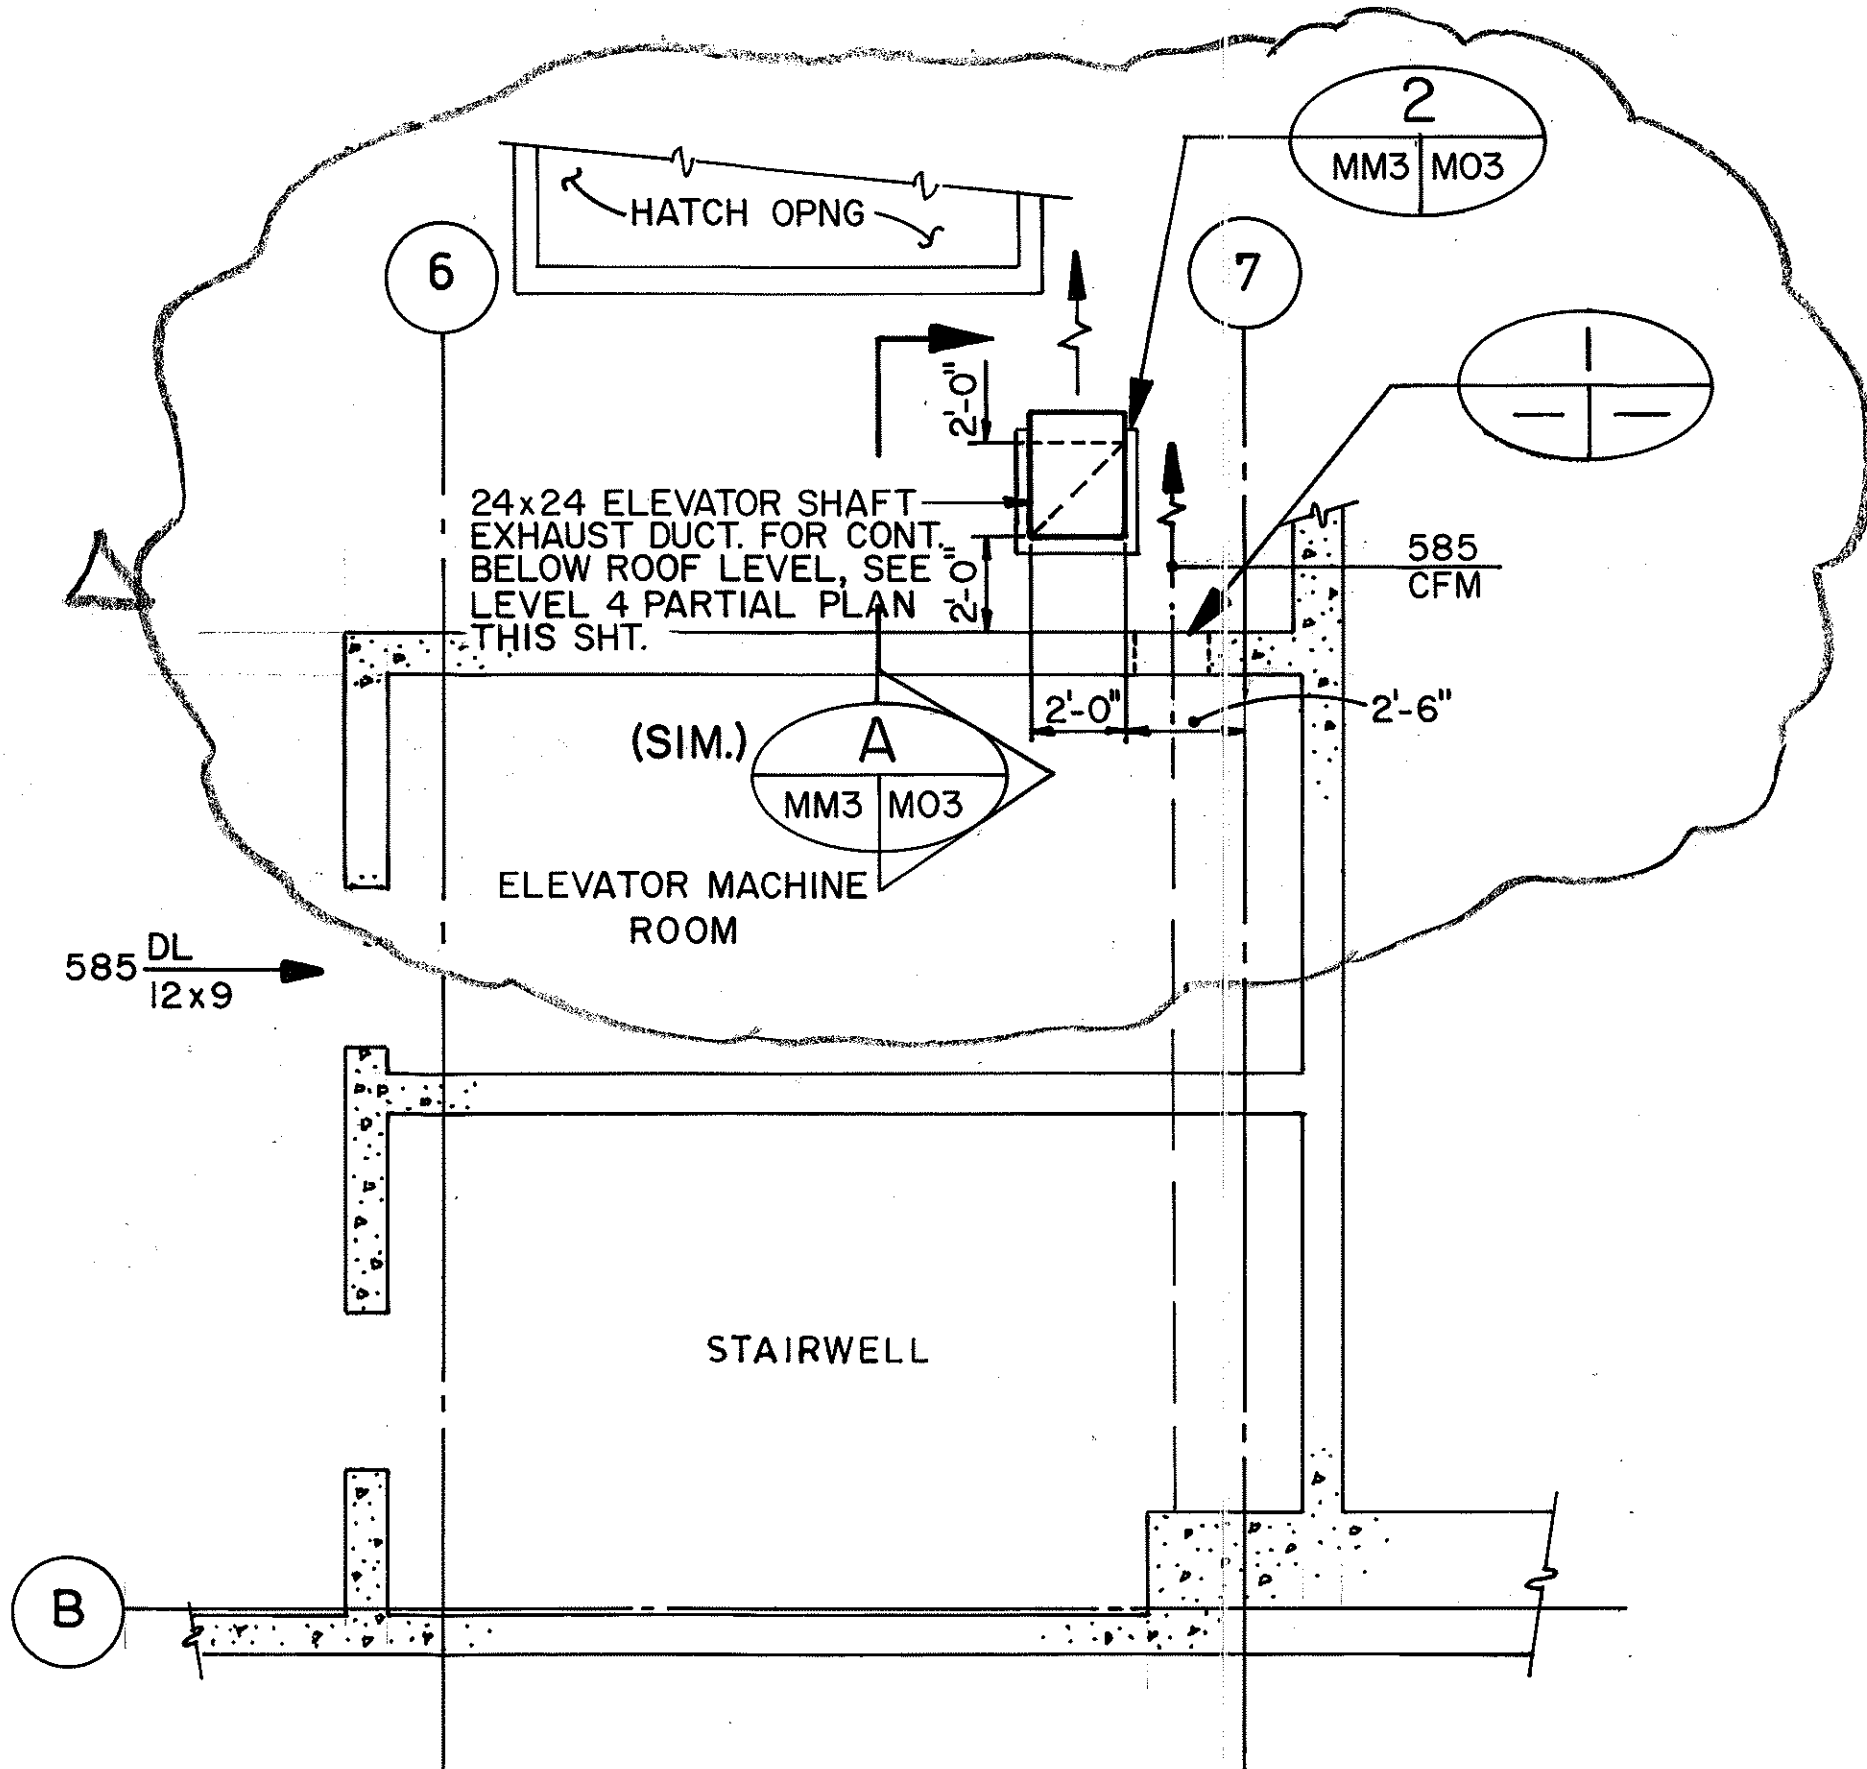


ROOF LEVEL PARTIAL PLAN
SCALE: 1/4"=1'-0"

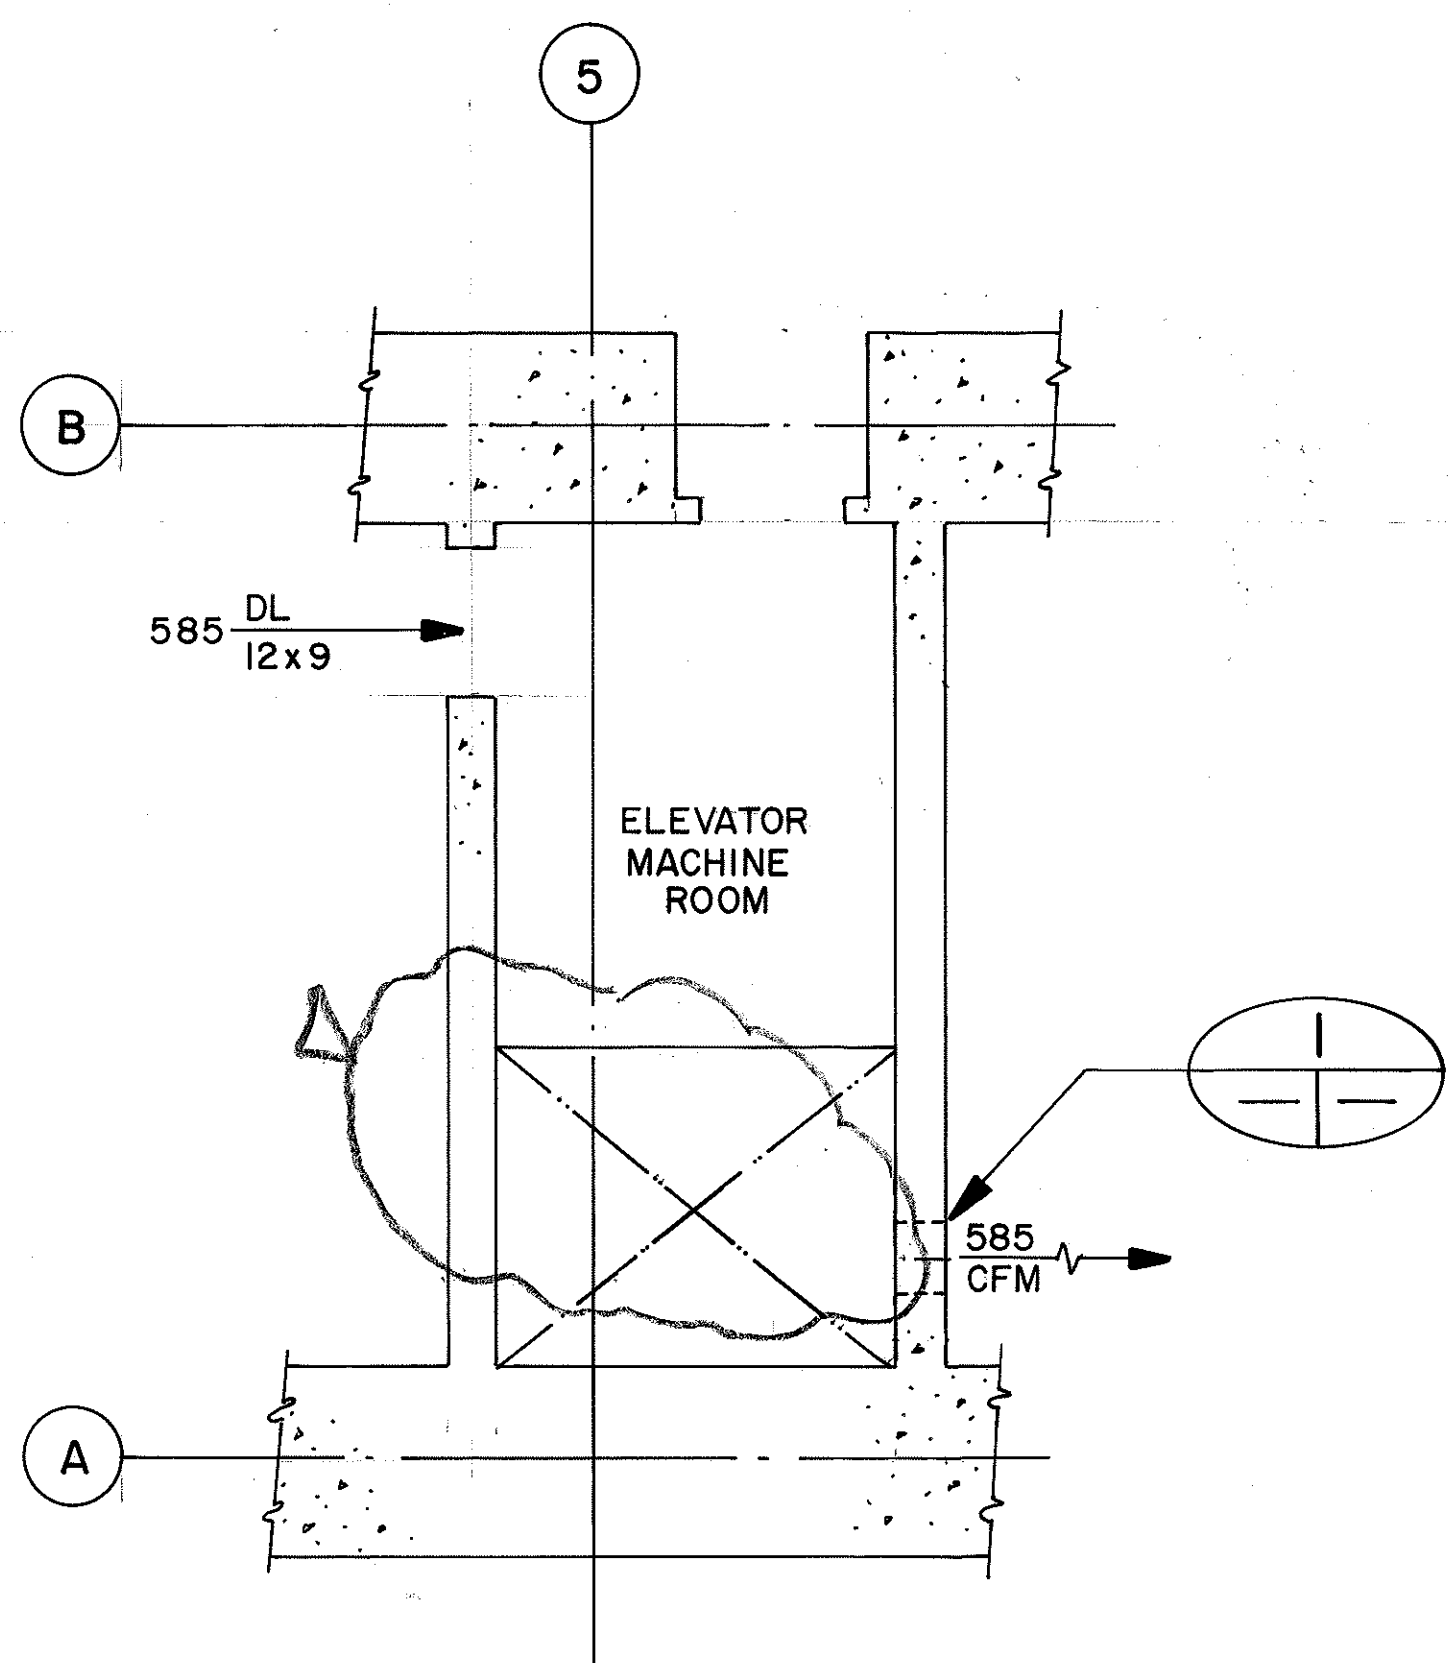


LEVEL 3 PARTIAL PLAN
SCALE: 1/4"=1'-0"


NOTE
FOR SAWCUT OPENINGS—BUSH HAMMER EXPOSED EDGES TO EVEN SURFACE, GRIND SMOOTH. PAINT EDGES OF OPENINGS AND EXPOSED REBAR WITH EPOXY PAINT.

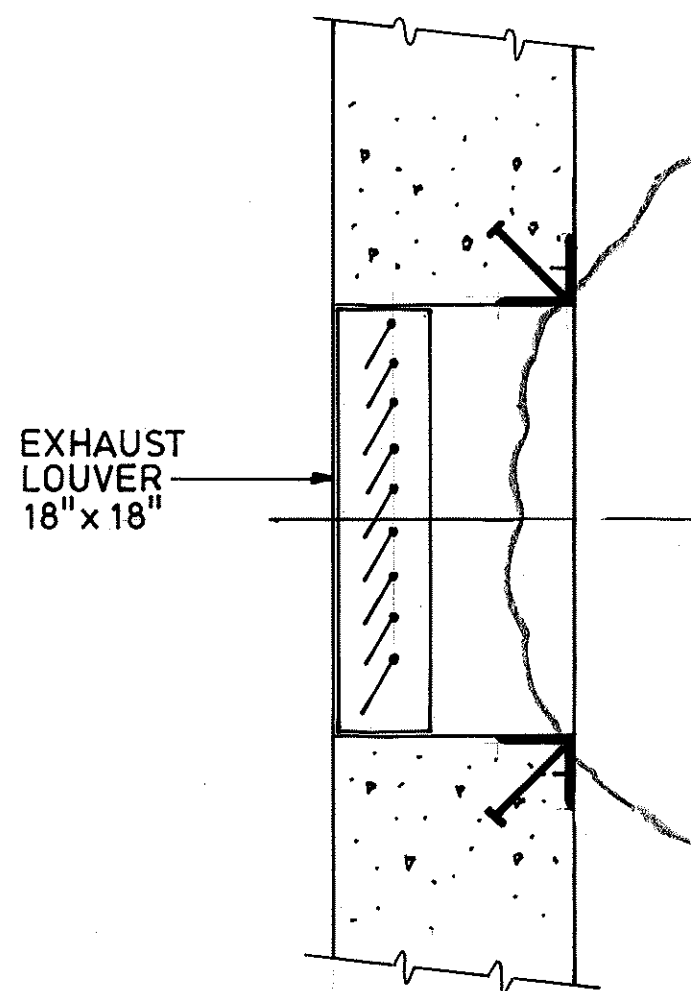



DETAIL
NO SCALE

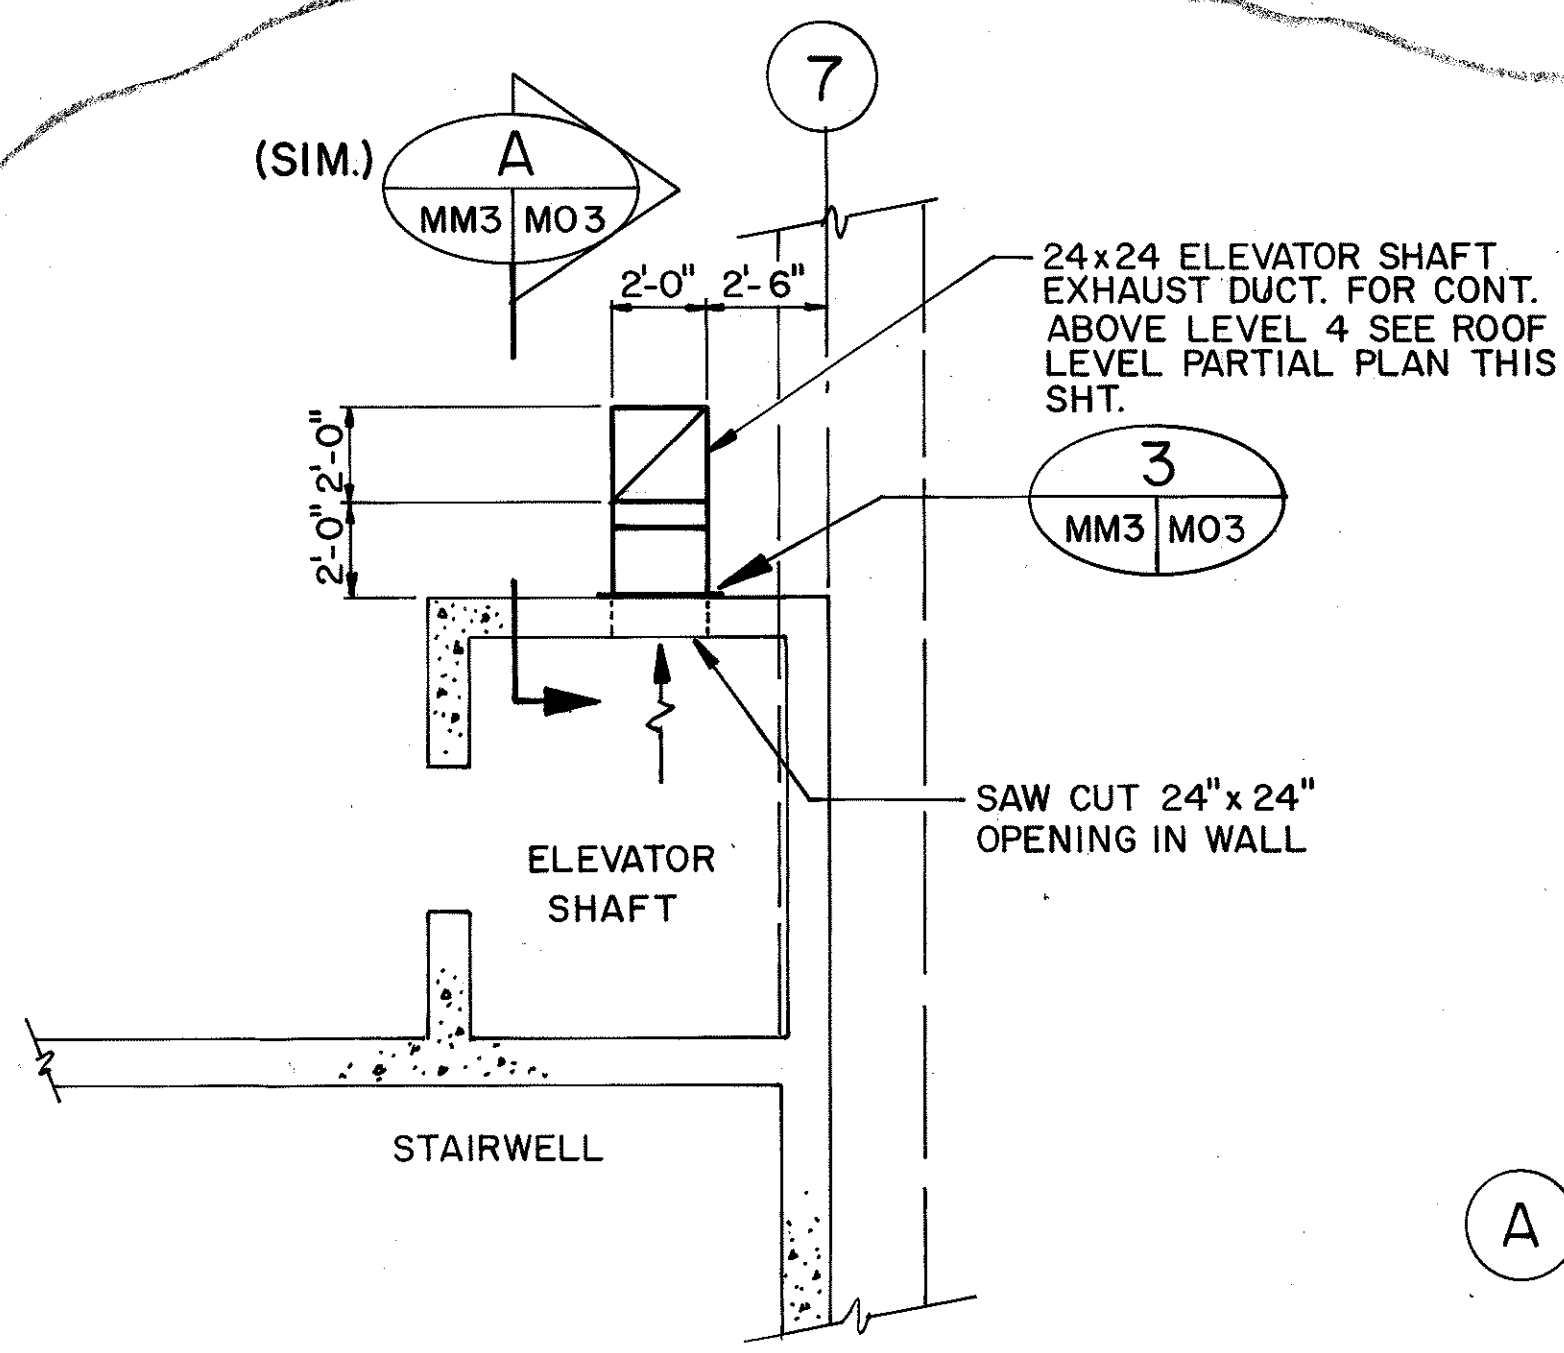

LEVEL 4 PARTIAL PLAN
SCALE: 1/4"=1'-0"

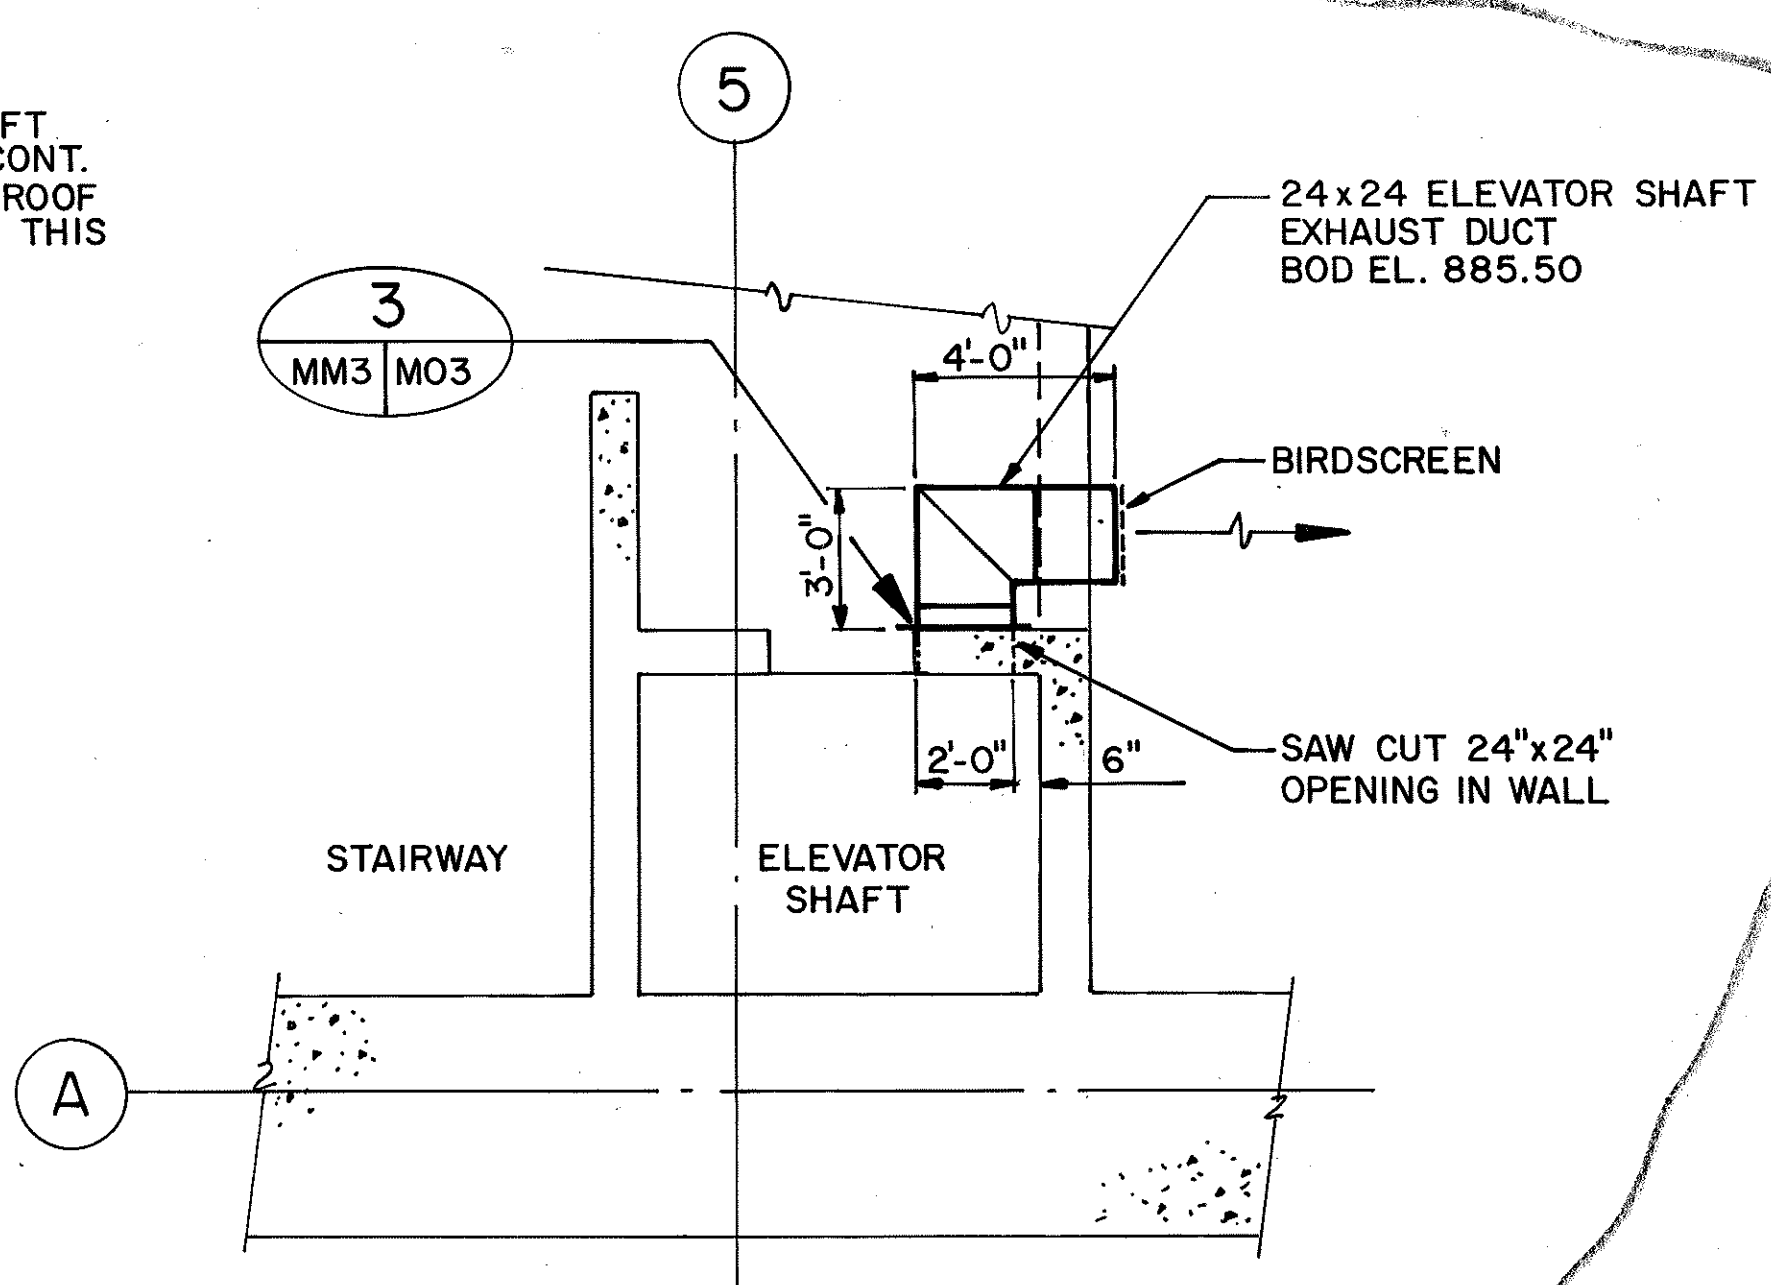

LEVEL 2 PARTIAL PLAN
SCALE: 1/4"=1'-0"

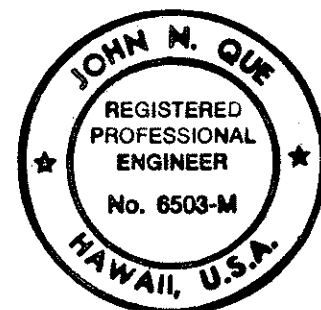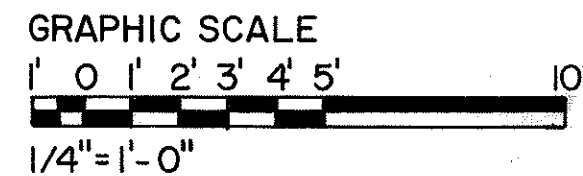


THIS WORK WAS PREPARED BY ME OR UNDER MY SUPERVISION


9/15/94	REV. PER DCN 66-052
DATE	REVISION
STATE OF HAWAII DEPARTMENT OF TRANSPORTATION HIGHWAYS DIVISION HVAC-ELEVATOR EQUIPMENT ROOMS-PLANS & DETAILS HAIKU PORTAL BUILDING - 1B INTERSTATE ROUTE H-3 F.A.I. PROJ. NO. I-H3-1(66)	
SCALE: AS NOTED	DATE: APR 1992
SHEET NO. MM3 OF 7 SHEETS	

ORIGINAL PLAN	DATE: 11/20/83
DRAWN BY: D.E. DRYDEN	DESIGNED BY: D.E. DRYDEN
CHECKED BY: J.N. QUE	DATE: 06/05/90


FED. ROAD DIST. NO.	STATE	FED. AID PROJ. NO.	FISCAL YEAR	SHEET NO.	TOTAL SHEET
HAWAII	HAW.	I-H3-1(66)	1992	82	440

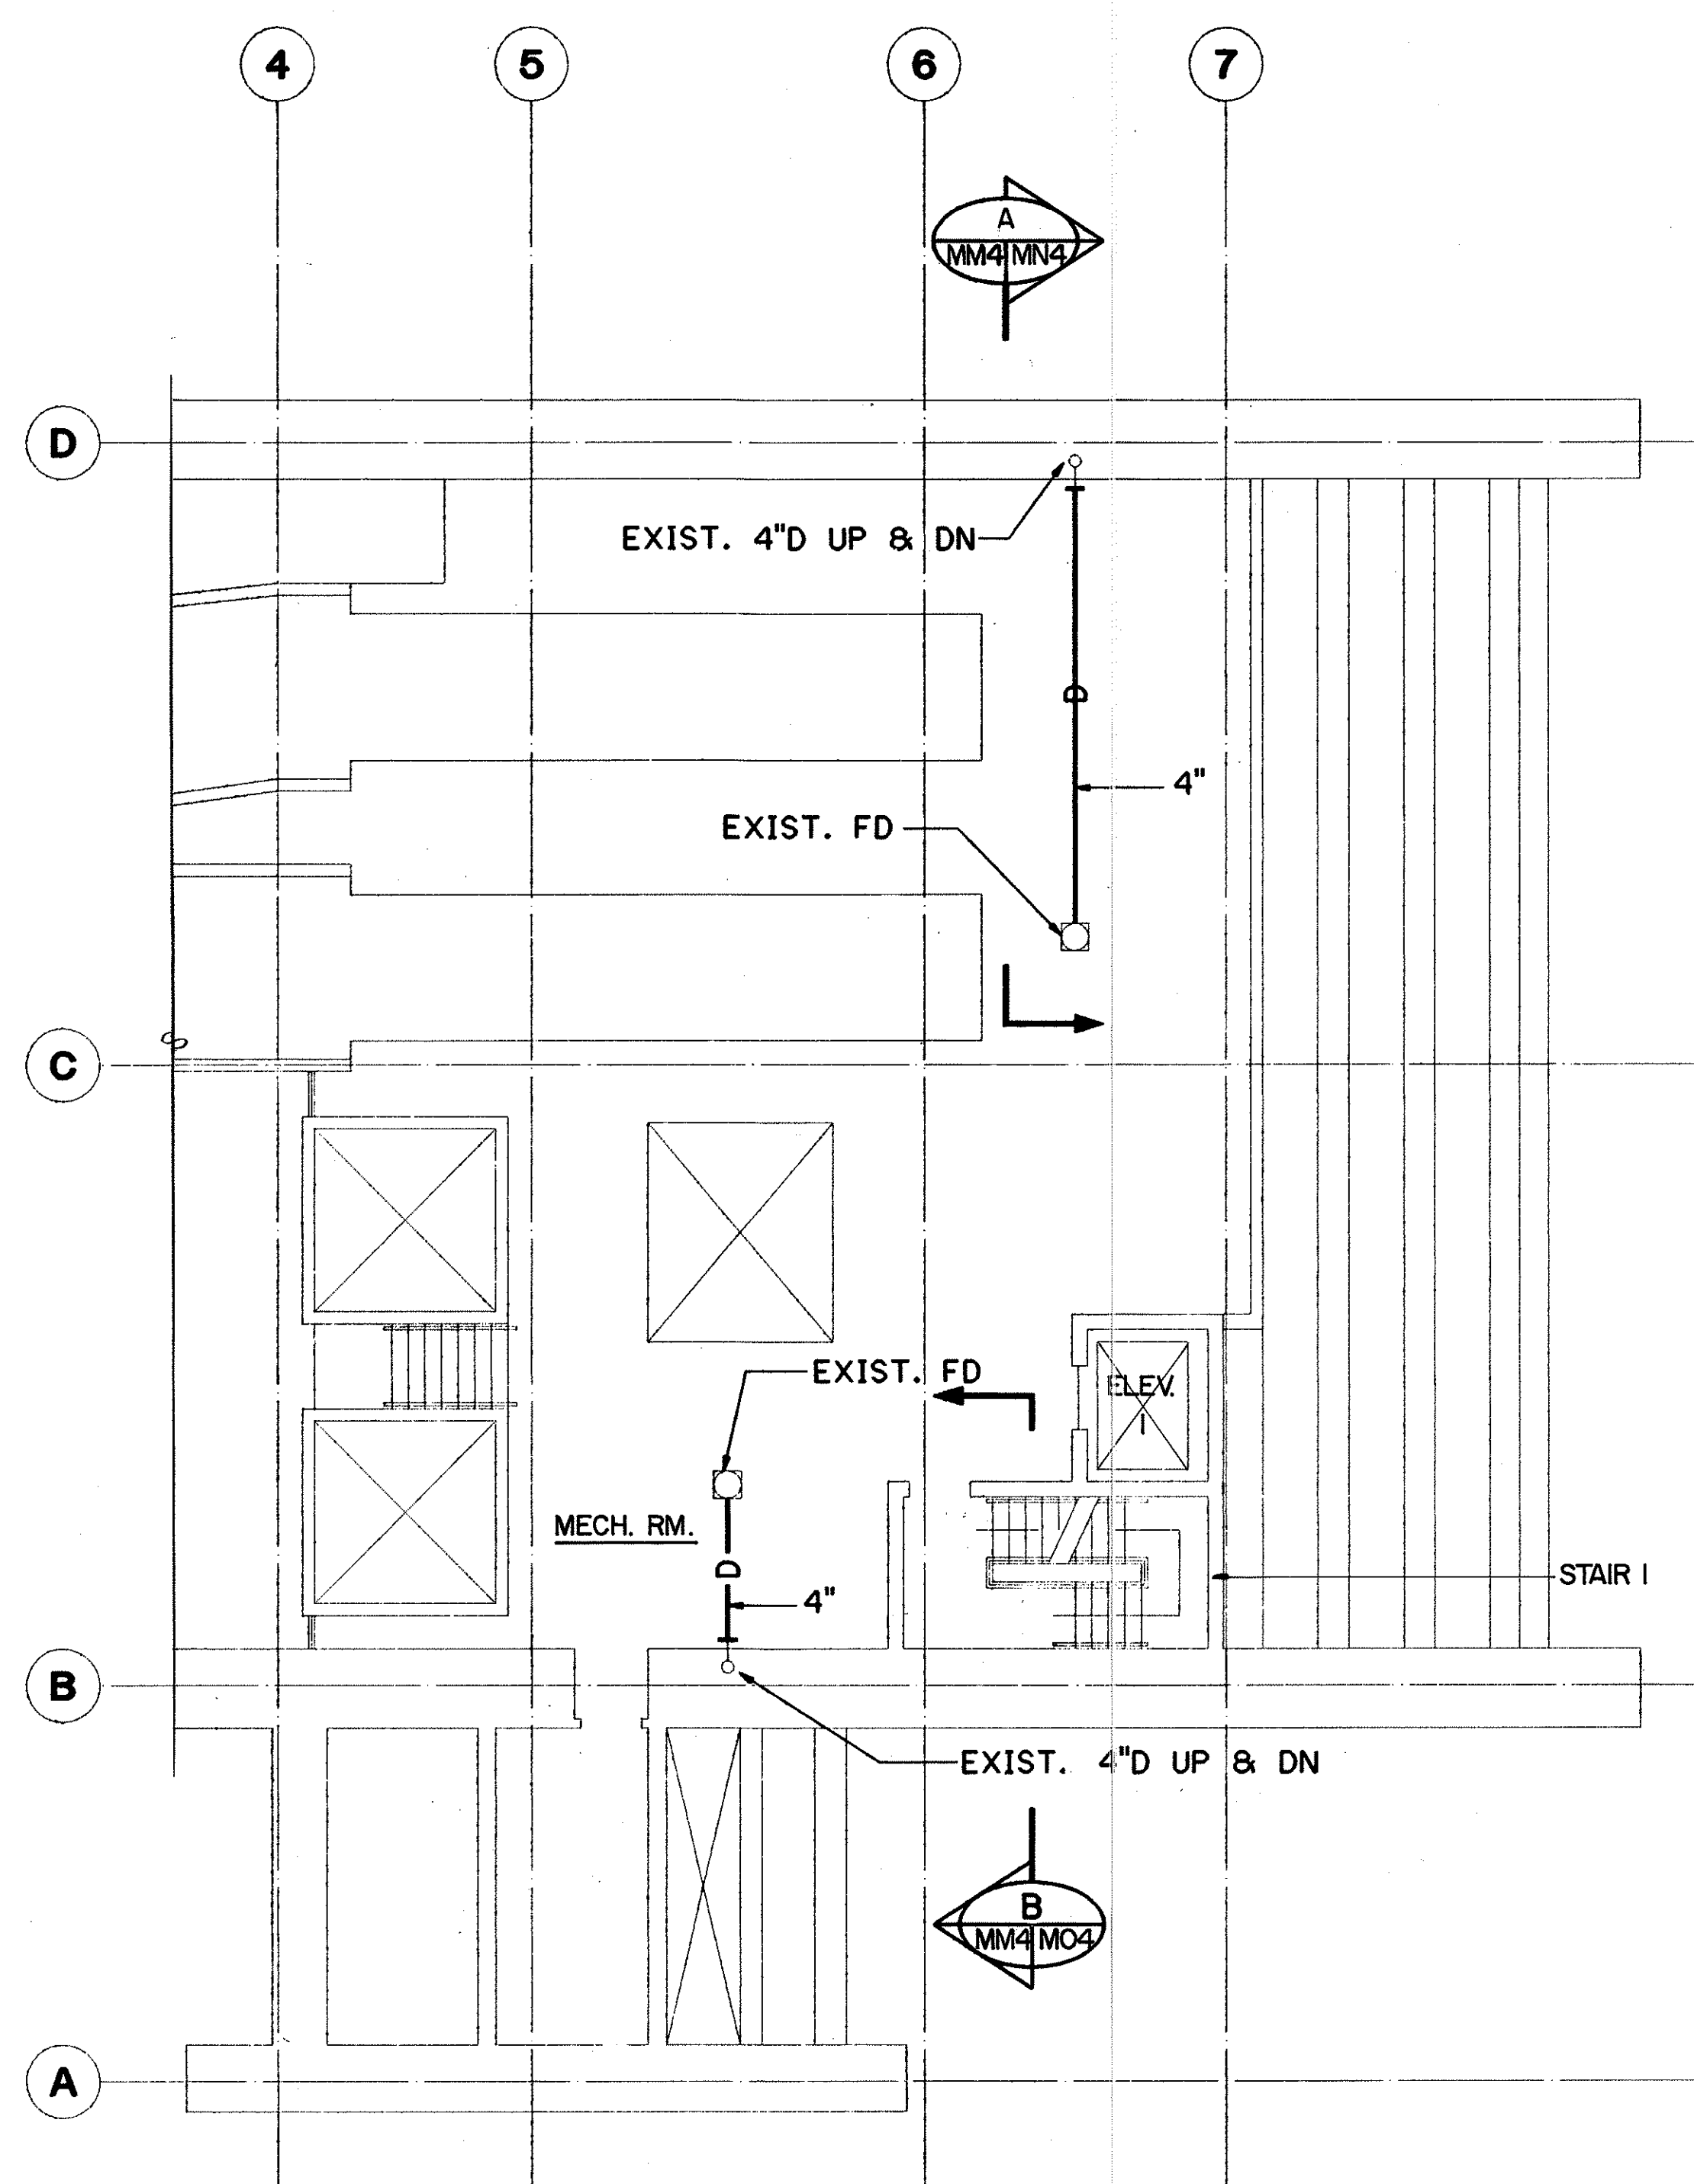

LEVEL 3 PARTIAL PLAN

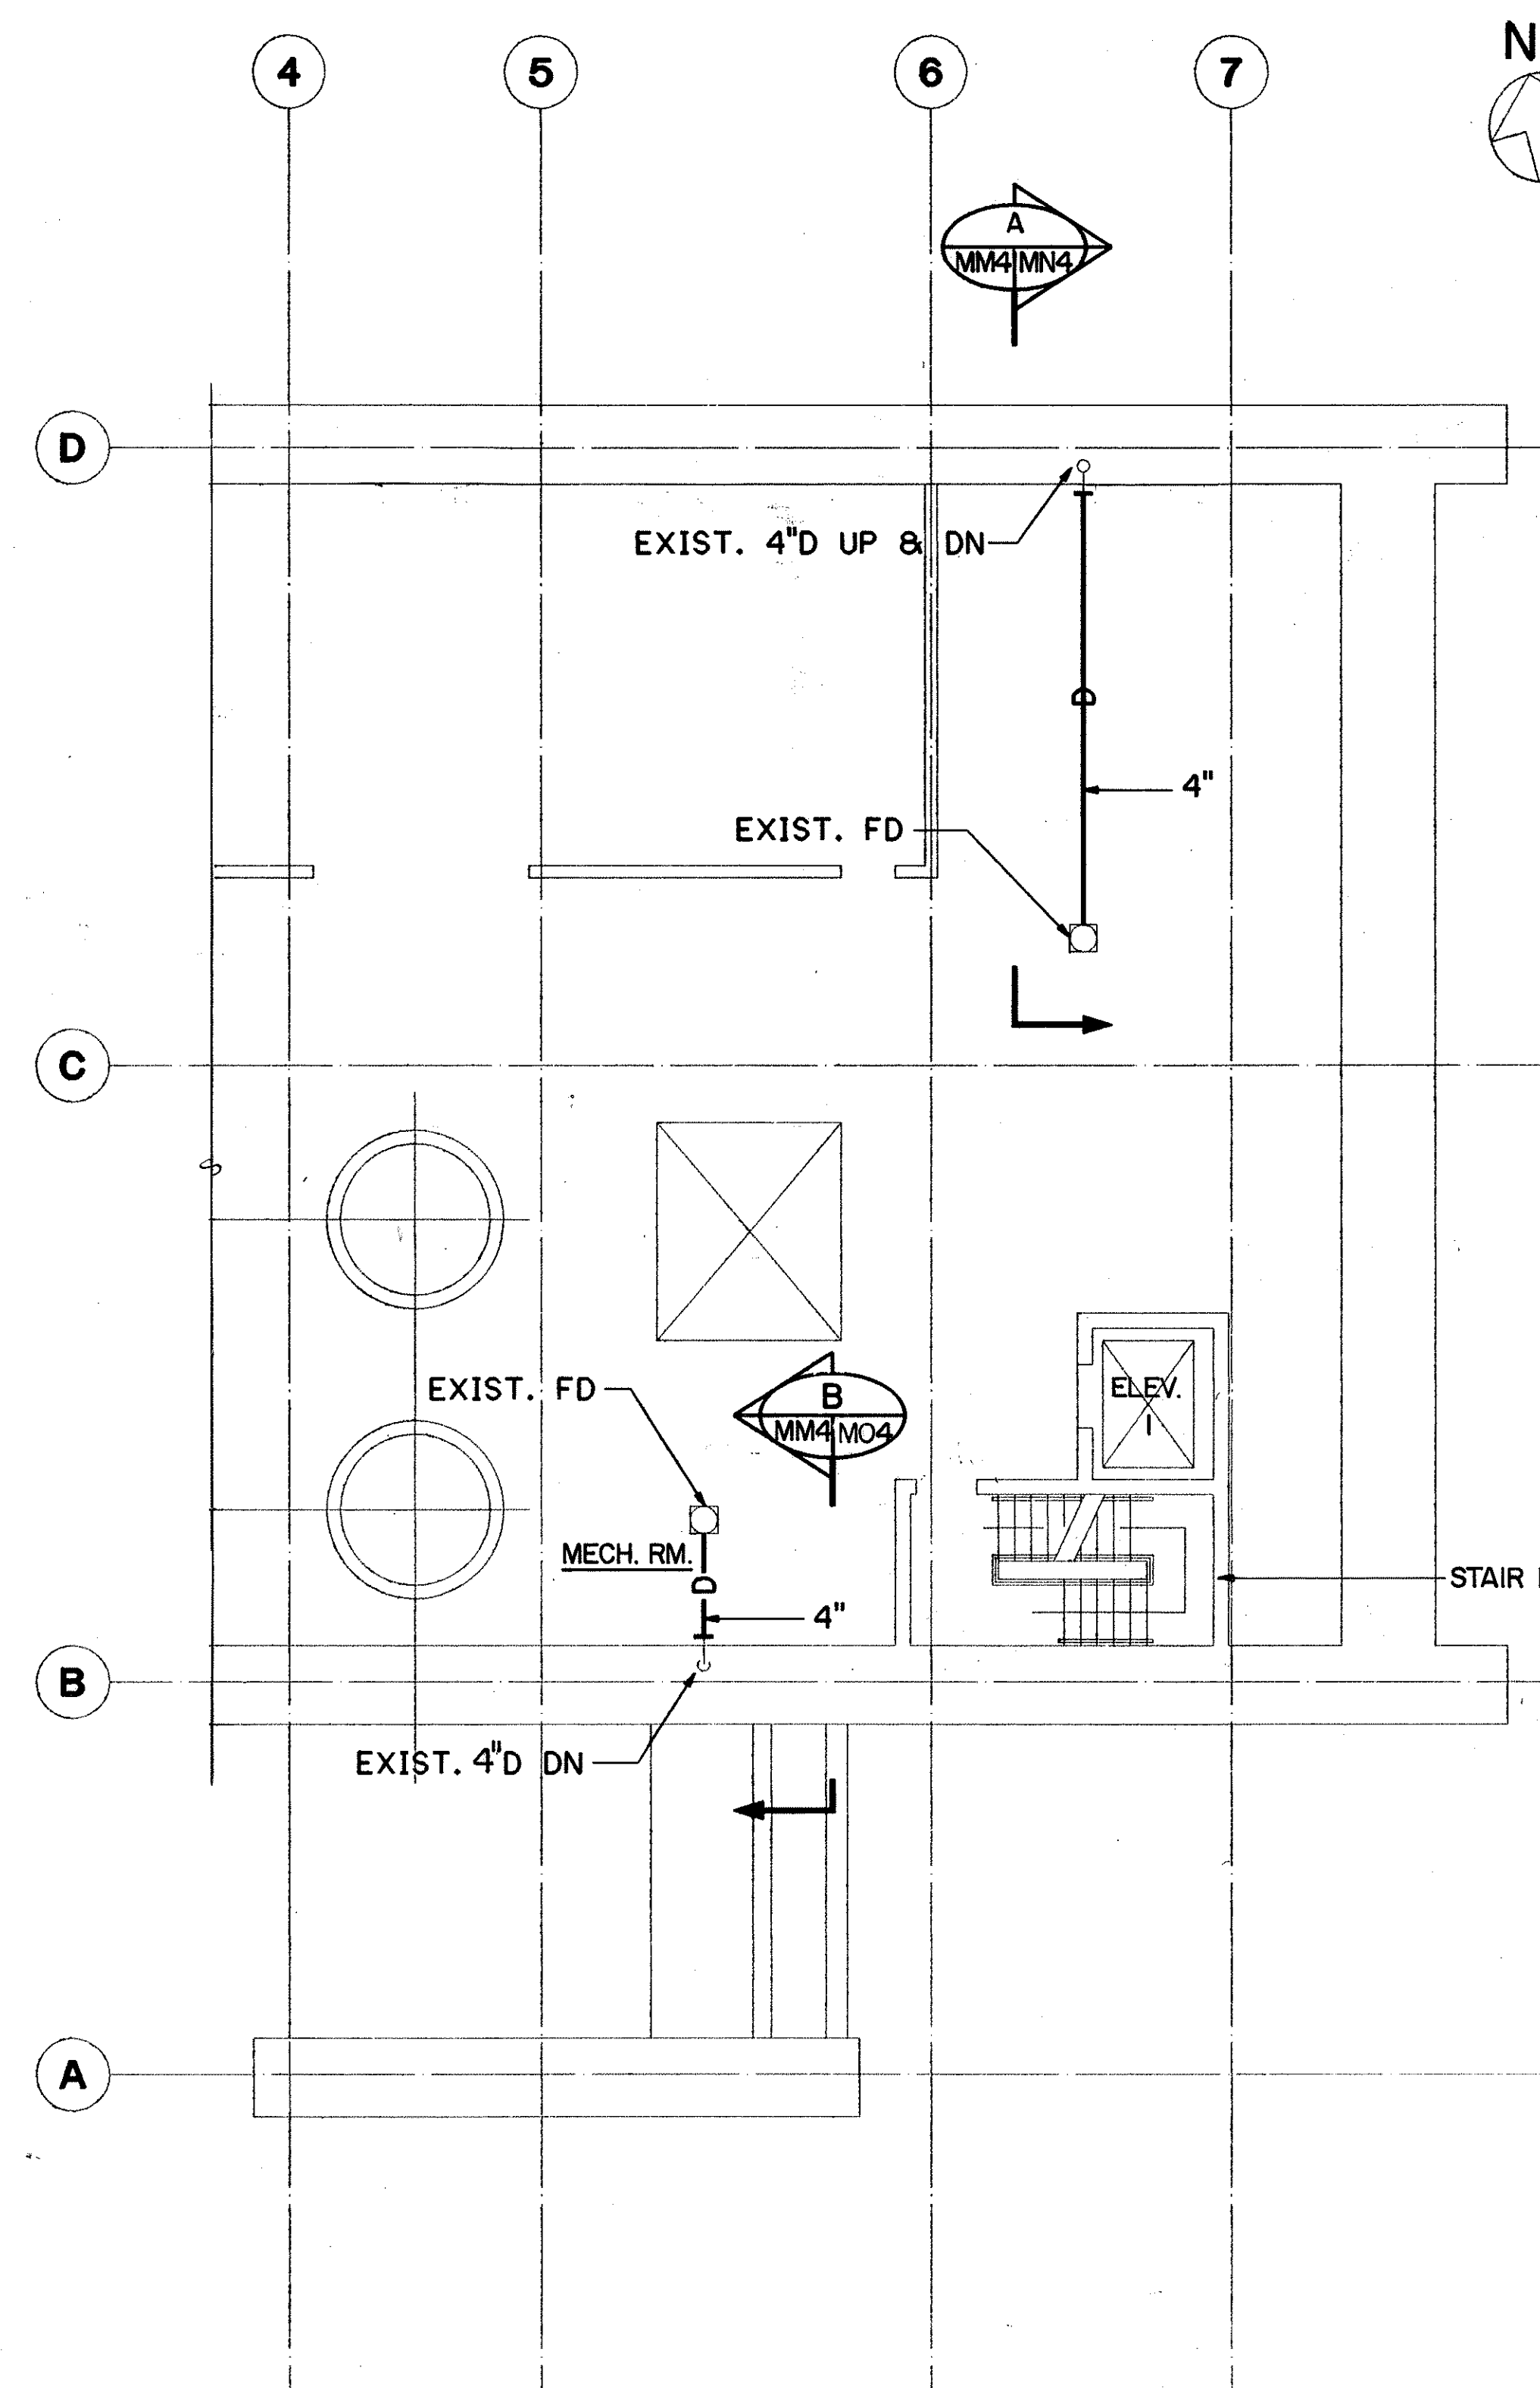

LEVEL 4 PARTIAL PLAN

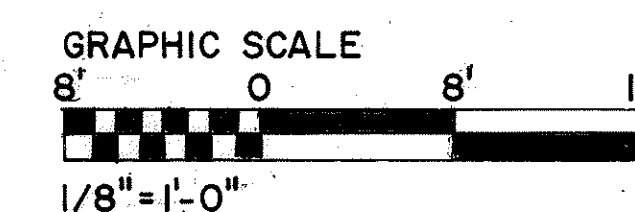

THIS WORK WAS PREPARED BY ME
OR UNDER MY SUPERVISION

John M. Doe

**STATE OF HAWAII
DEPARTMENT OF TRANSPORTATION
HIGHWAYS DIVISION**

PLUMBING-LEVEL 3 & LEVEL 4 PARTIAL PLANS

**HAIKU PORTAL BUILDING-IB
INTERSTATE ROUTE H-3
F.A.I. PROJ. NO. I-H3-I(66)**


SCALE: ¼"=1'-0"

DATE: APR 7 1992

SHEET NO. **MM4** **OF** **7** **SHEETS**


ORIGINAL PLAN	SURVEY PLOTTED BY _____ DATE <u>01/12/89</u>
NOTE BOOK	DRAWN BY _____ CADD _____
NO.	TRACED BY _____
	DESIGNED BY <u>P. L. LALQUE</u>
	QUANTITIES BY _____
	CHECKED BY <u>J. N. QUE</u>
	<u>05/01/90</u>

FED. ROAD DIST. NO.	STATE	FED. AID PROJ. NO.	FISCAL YEAR	SHEET NO.	TOTAL SHEETS
HAWAII	HAW.	I-H3-1(66)	1992	83	440

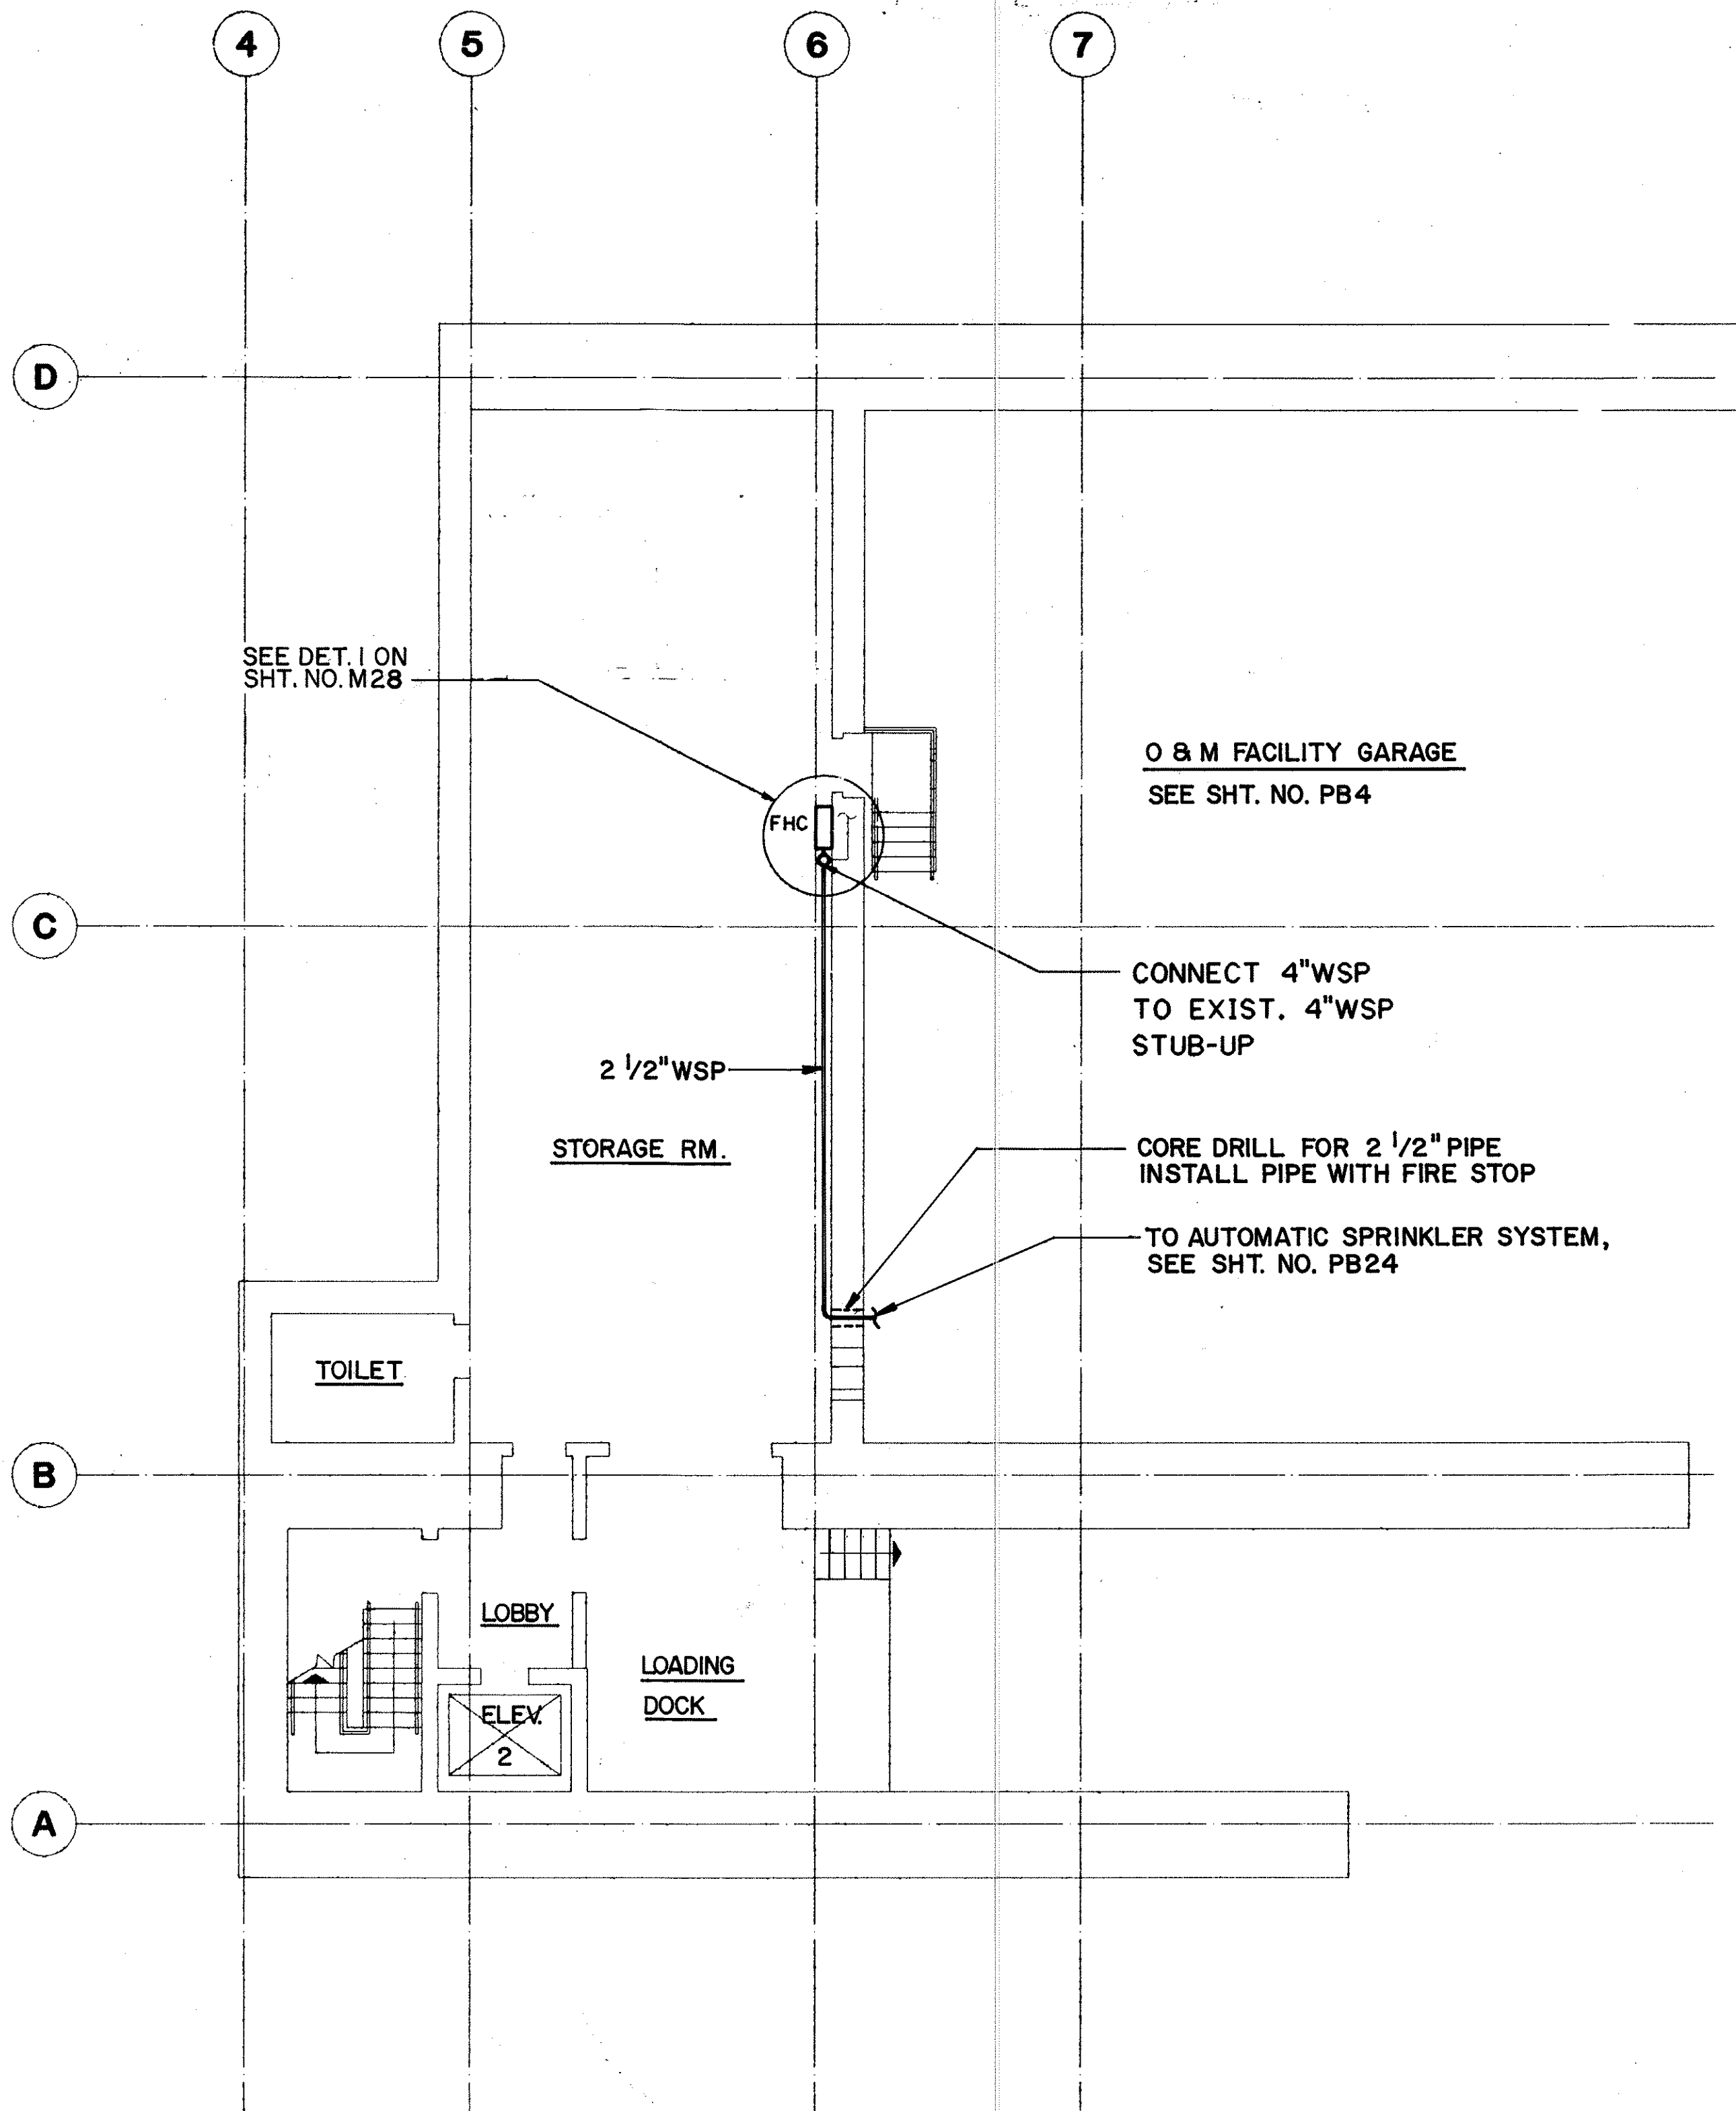


LEVEL A PARTIAL PLAN

SCALE: 1/8" = 1'-0"

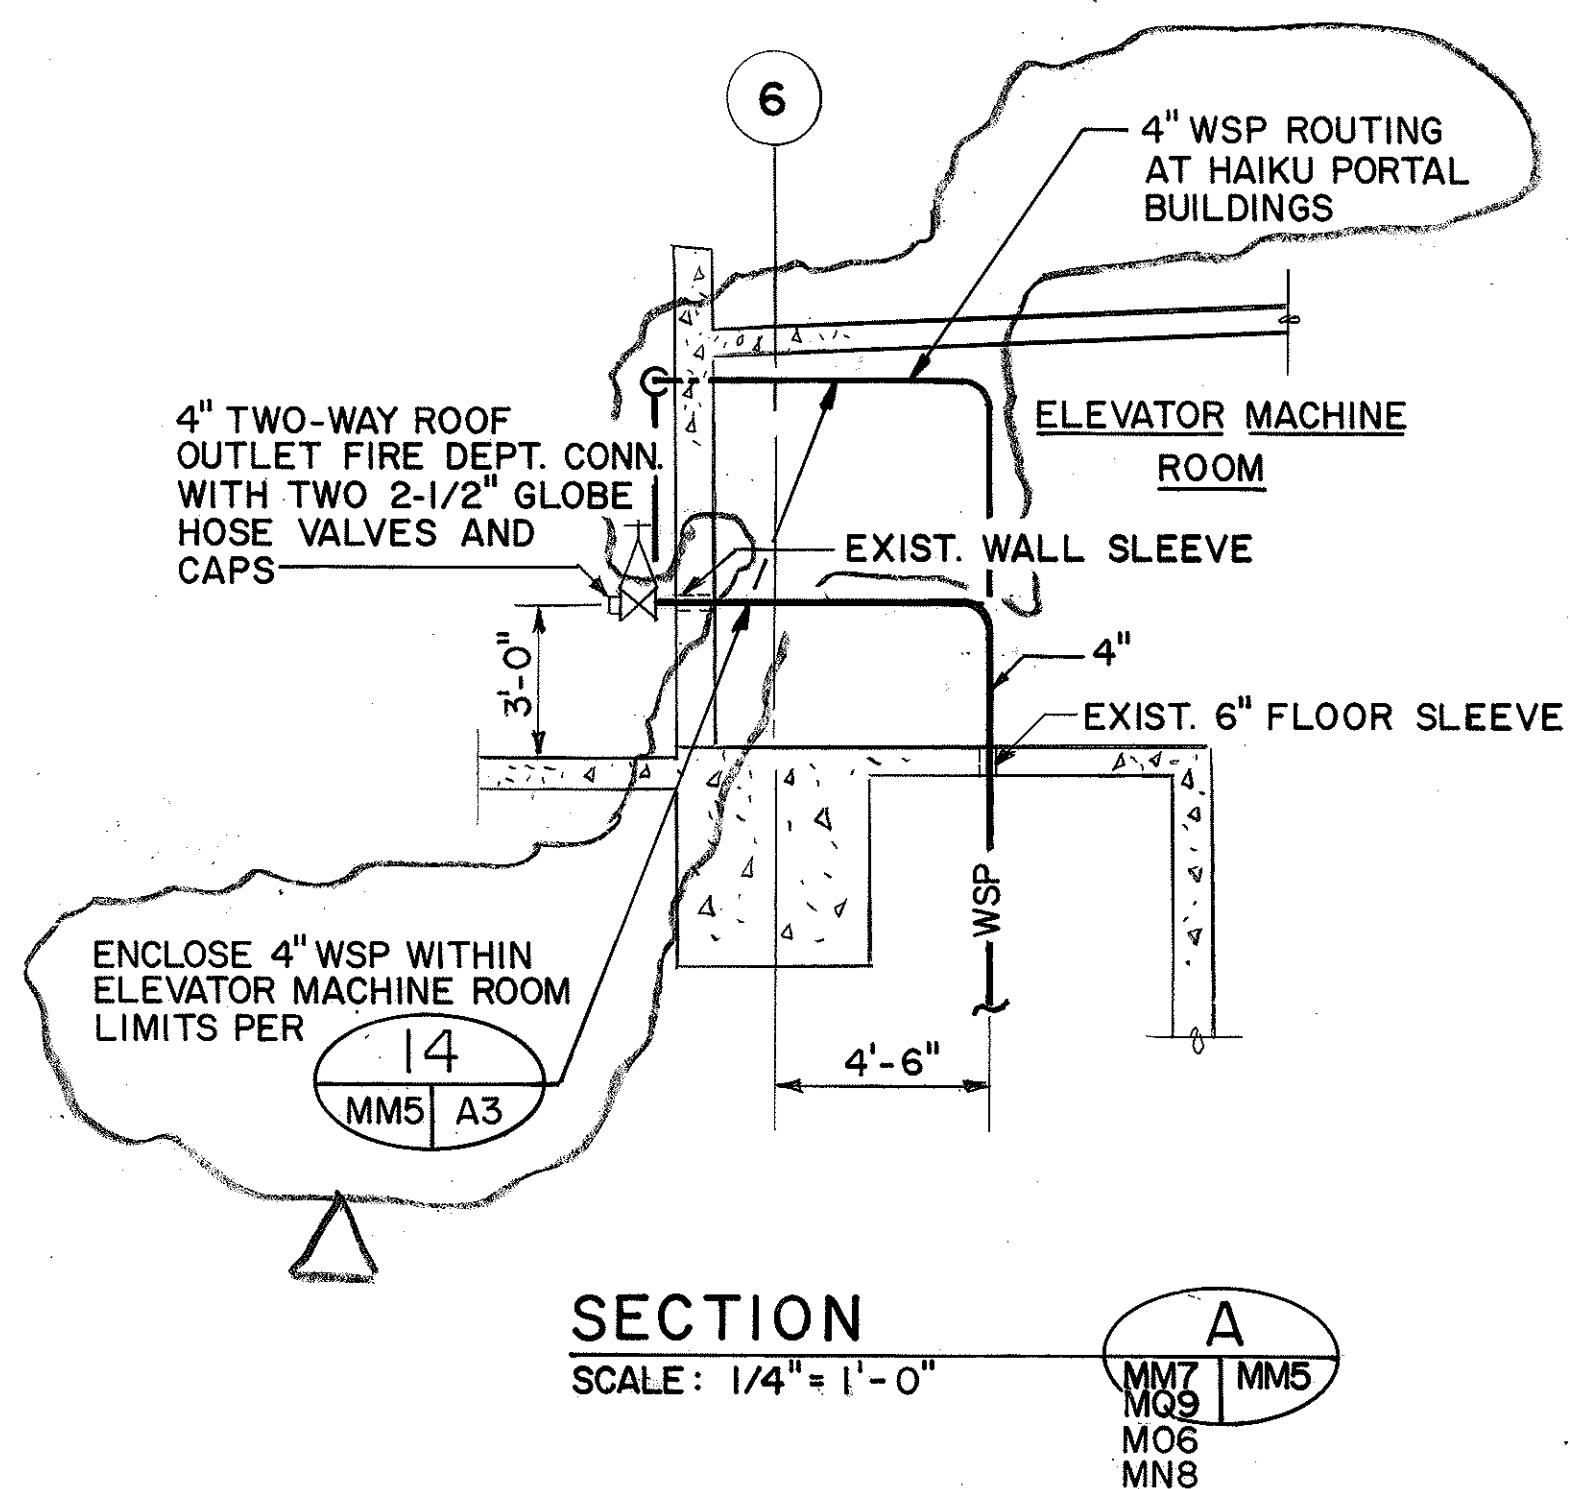

SECTION



SCALE: 1/4" = 1'-0"

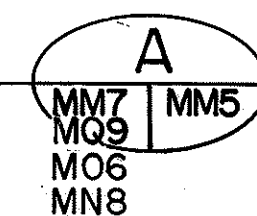

FOR DETAIL AS-BUILT INFORMATION
REFER TO CONSTRUCTION SUBMITTALS

DATE	REVISION
9/19/94	REV. PER DCN 66-052
7/22/92	ADDENDUM 1-ADDED WSP TO O & M GARAGE
STATE OF HAWAII DEPARTMENT OF TRANSPORTATION HIGHWAYS DIVISION FIRE PROTECTION - LEVEL A PARTIAL PLAN HAIKU PORTAL BUILDING-IB INTERSTATE ROUTE H-3 F.A.I. PROJ. NO. I-H3-1(66) SCALE: AS NOTED DATE: APR 1992 SHEET NO. MM5 OF 7 SHEETS	


GRAPHIC SCALES

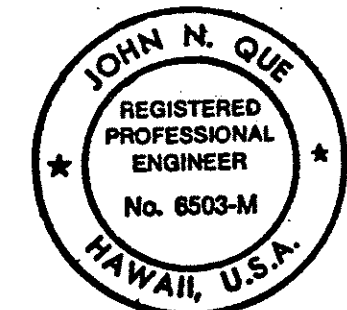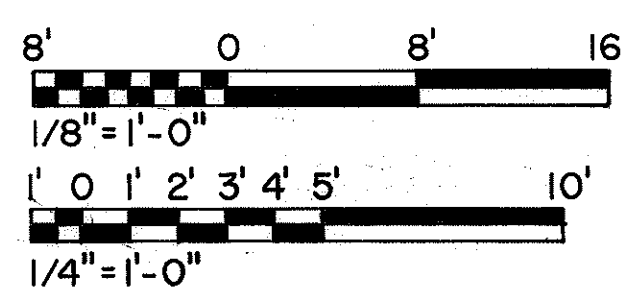


THIS WORK WAS PREPARED BY ME
OR UNDER MY SUPERVISION

John N. Que



FED. ROAD DIST. NO.	STATE	FED. AID PROJ. NO.	FISCAL YEAR	SHEET NO.	TOTAL SHEETS
HAWAII	HAW.	I-H3-1(66)	1992	85	440

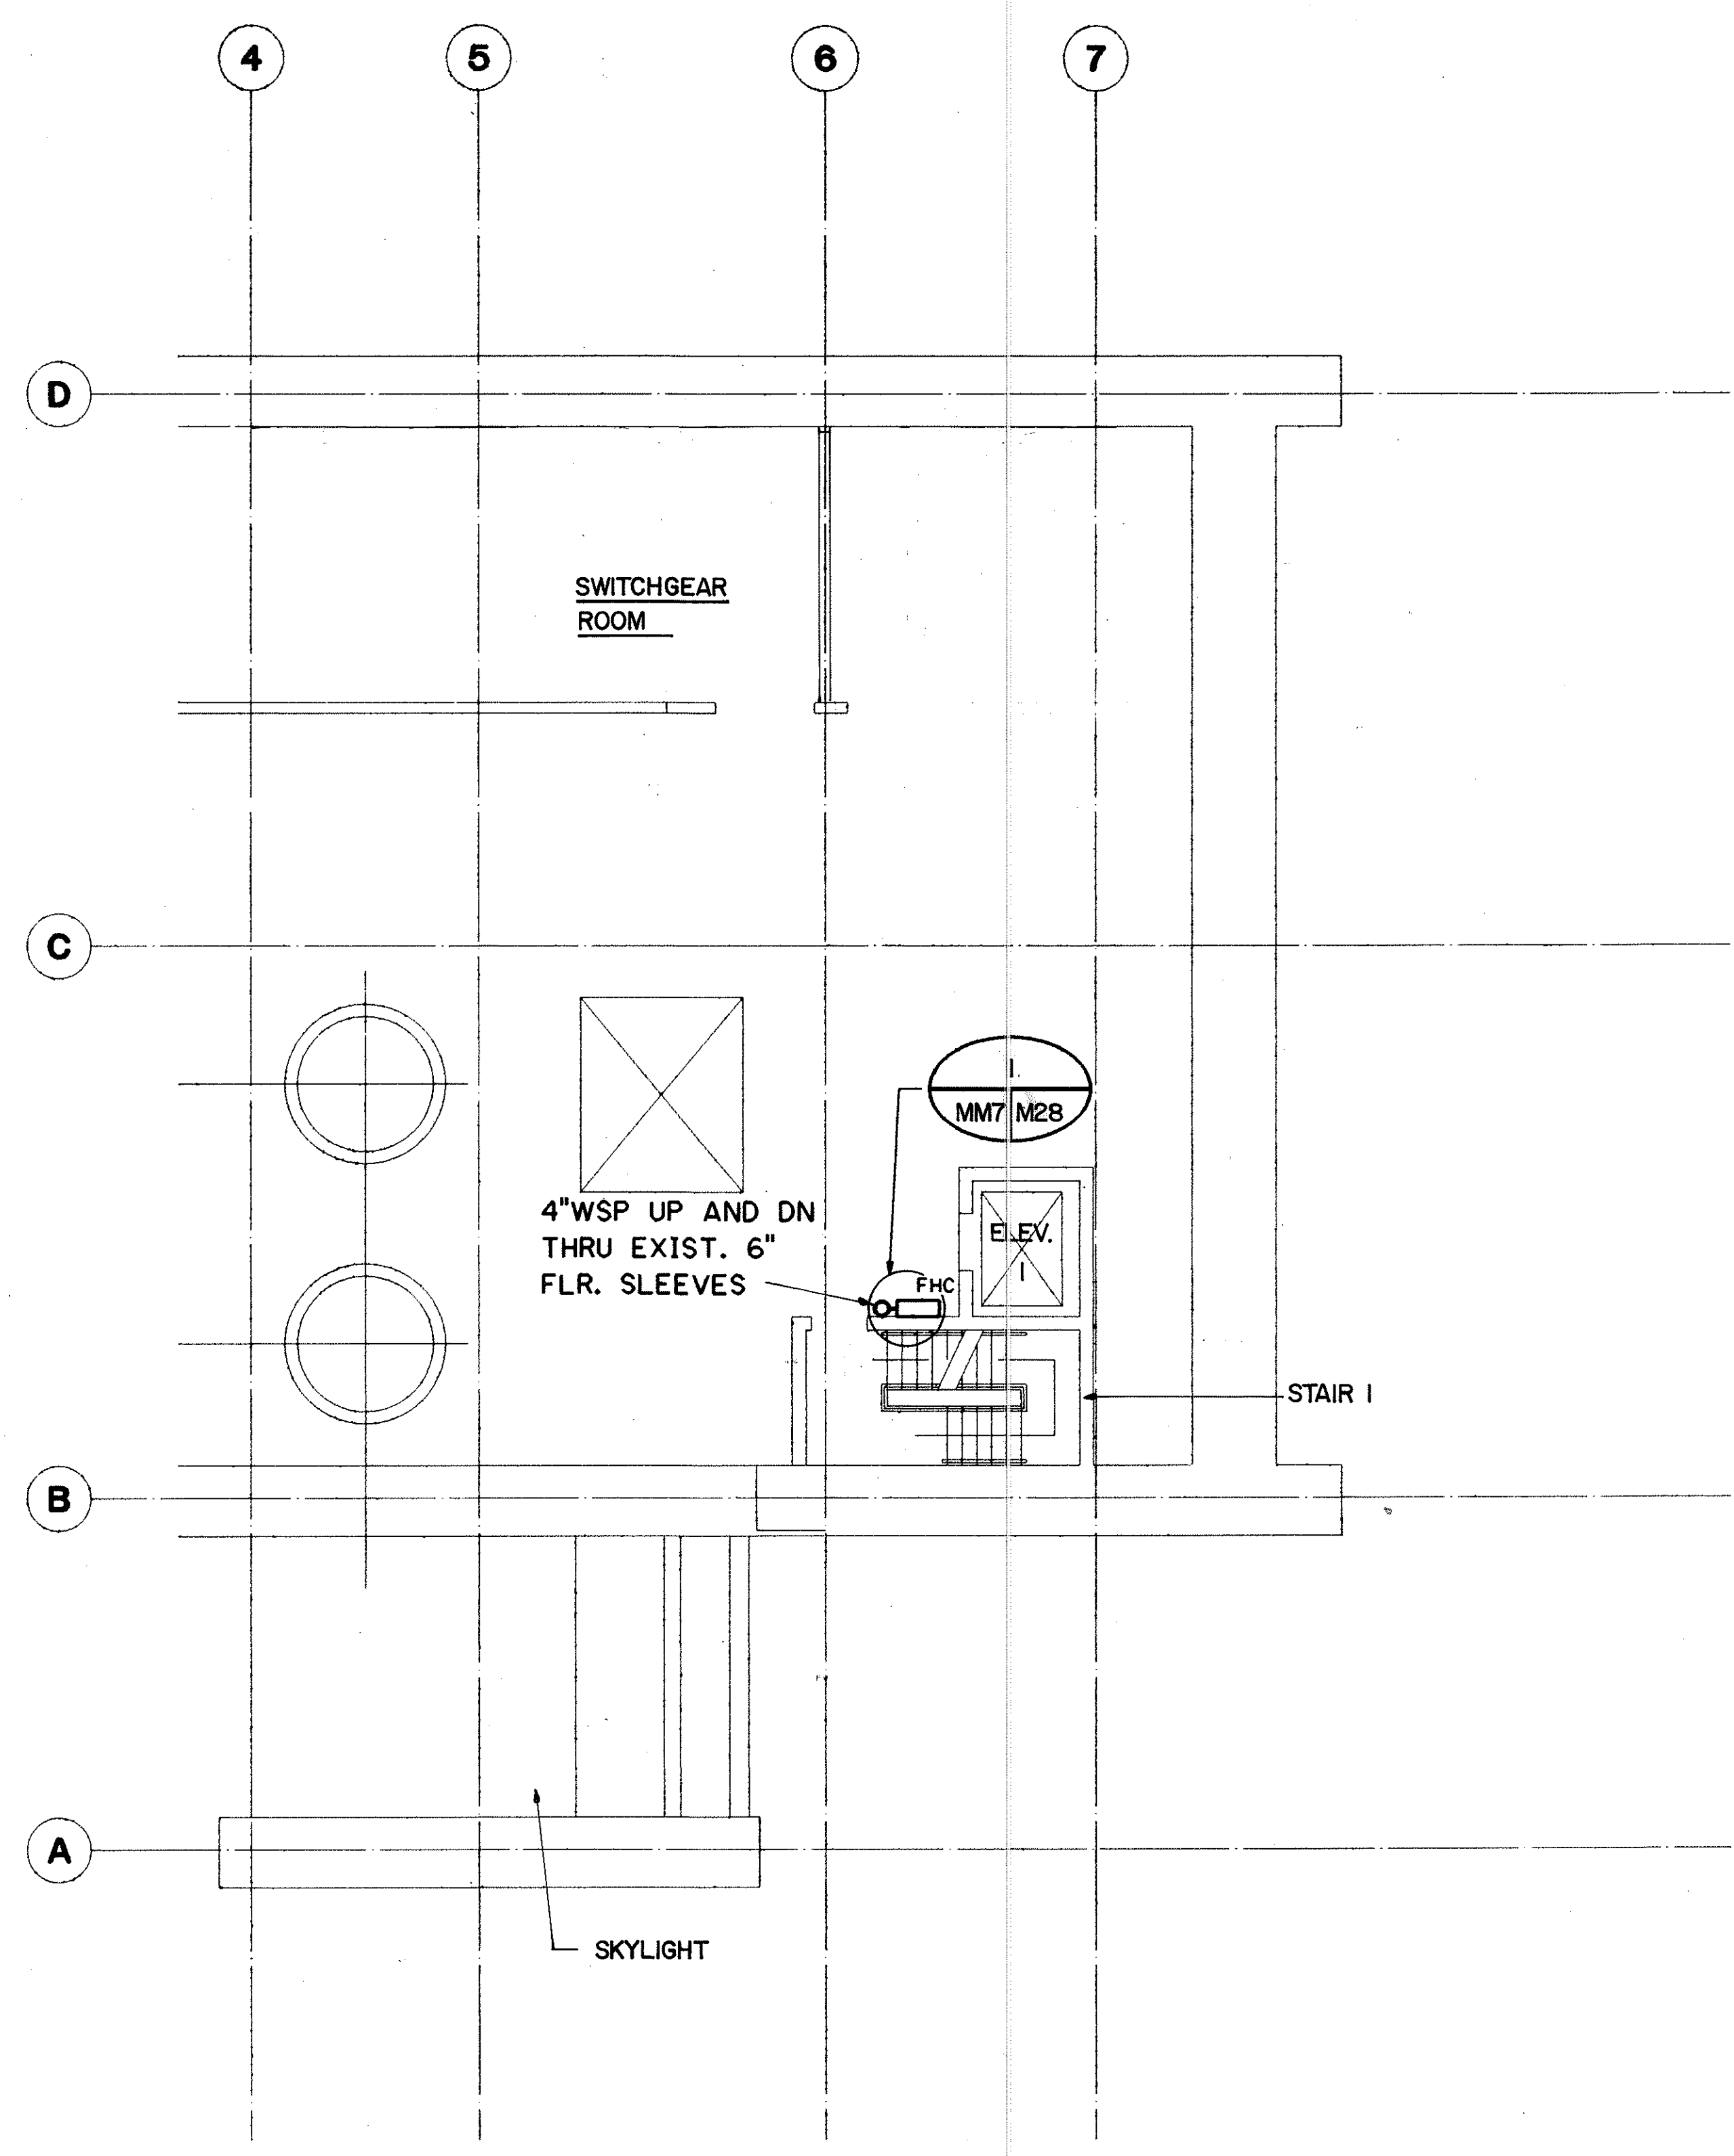

LEVEL 4 PARTIAL PLAN

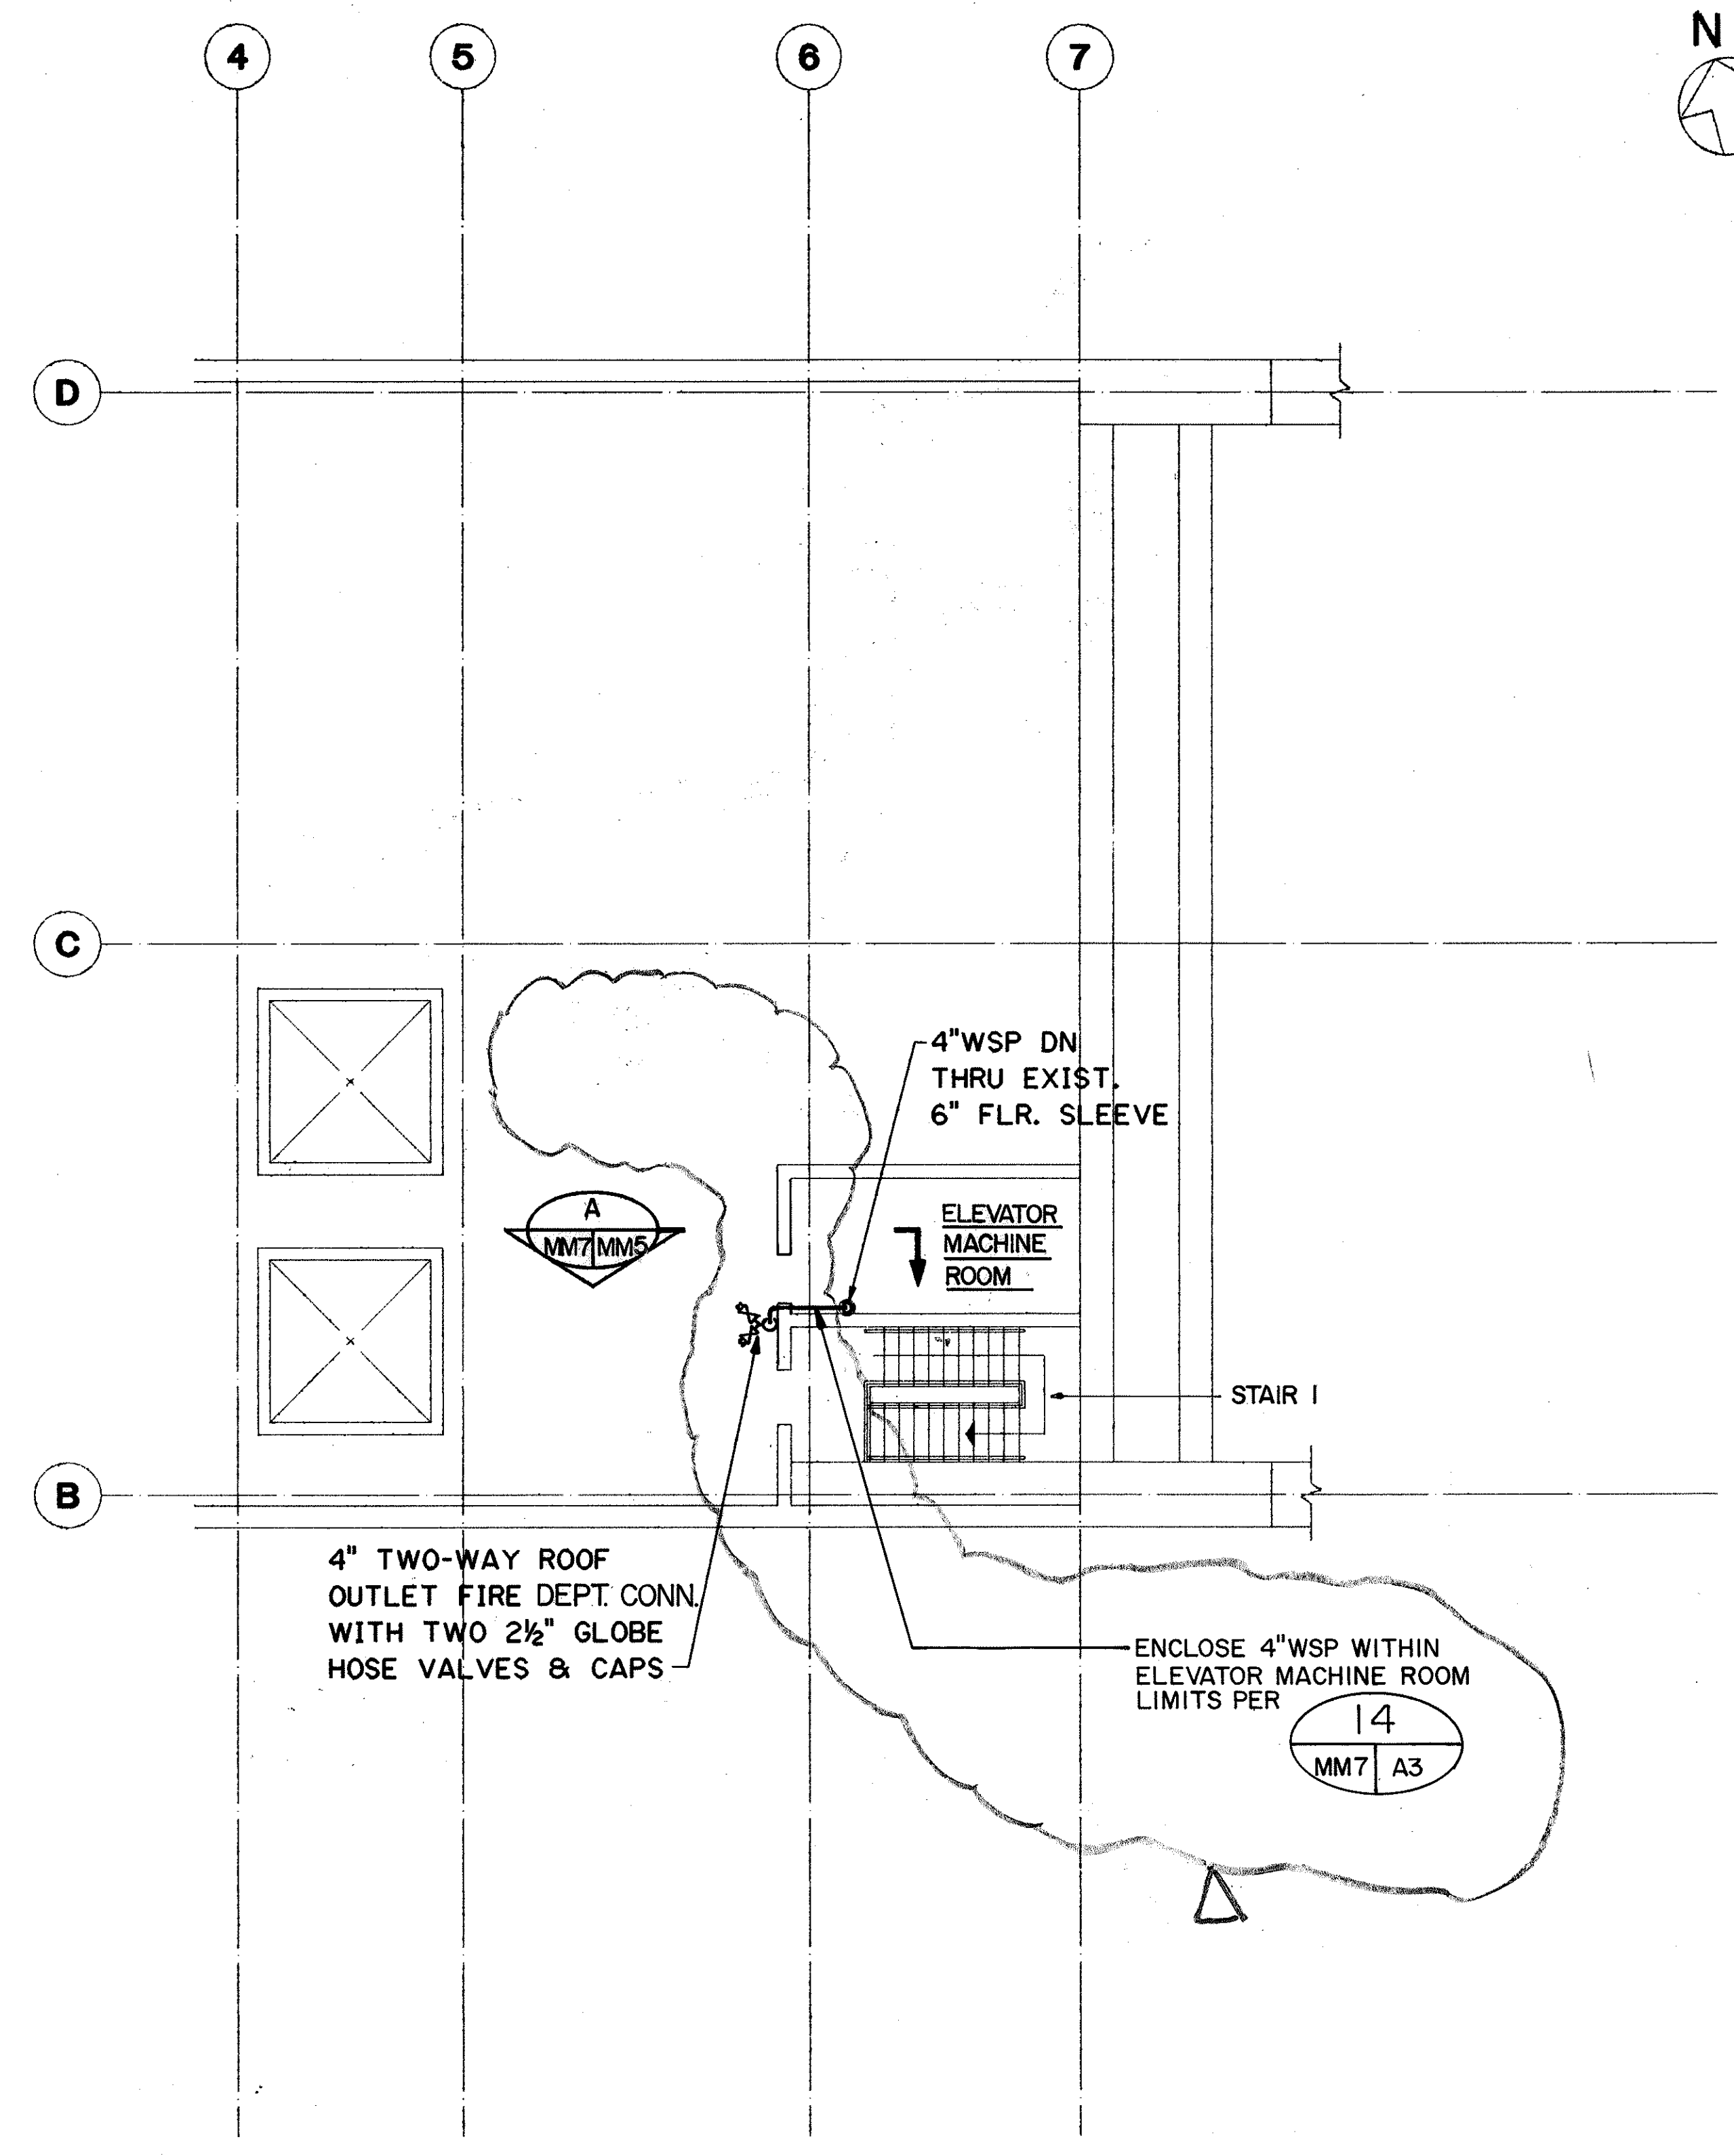

ROOF LEVEL PARTIAL PLAN

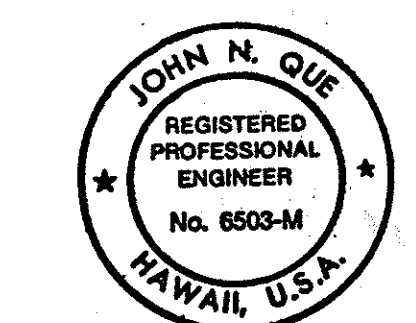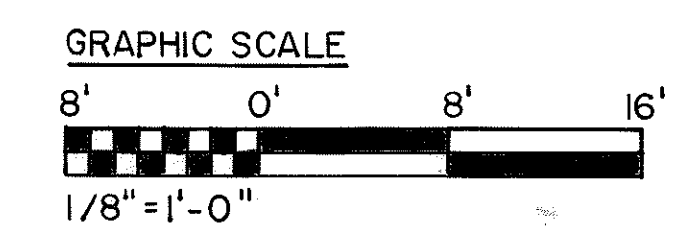

THIS WORK WAS PREPARED BY ME OR UNDER MY SUPERVISION

John N. Que

9/19/94	REV. PER DCN 66-052
DATE	REVISION

STATE OF HAWAII
DEPARTMENT OF TRANSPORTATION
HIGHWAYS DIVISION

**FIRE PROTECTION-LEVEL 4
& ROOF PARTIAL PLANS**



HAIKU PORTAL BUILDING - 1B
INTERSTATE ROUTE H-3
F.A.I. PROJ. NO. I-H3-1(66)

SCALE 1/8"=1'-0" DATE: APR. 1992

SHEET NO. MM7 OF 7 SHEETS



SURVEY PLOTTED BY	DATE
B. BUNYI	1/15/89
DESIGNED BY	
P. L. LALOU	1/10/89
QUANTITIES BY	
J. N. QUE	06/01/90
NO.	

FED. ROAD DIST. NO.	STATE	FED. AID PROJ. NO.	FISCAL YEAR	SHEET NO.	TOTAL SHEETS
HAWAII	HAW.	I-H3-1(66)	1992	86	440

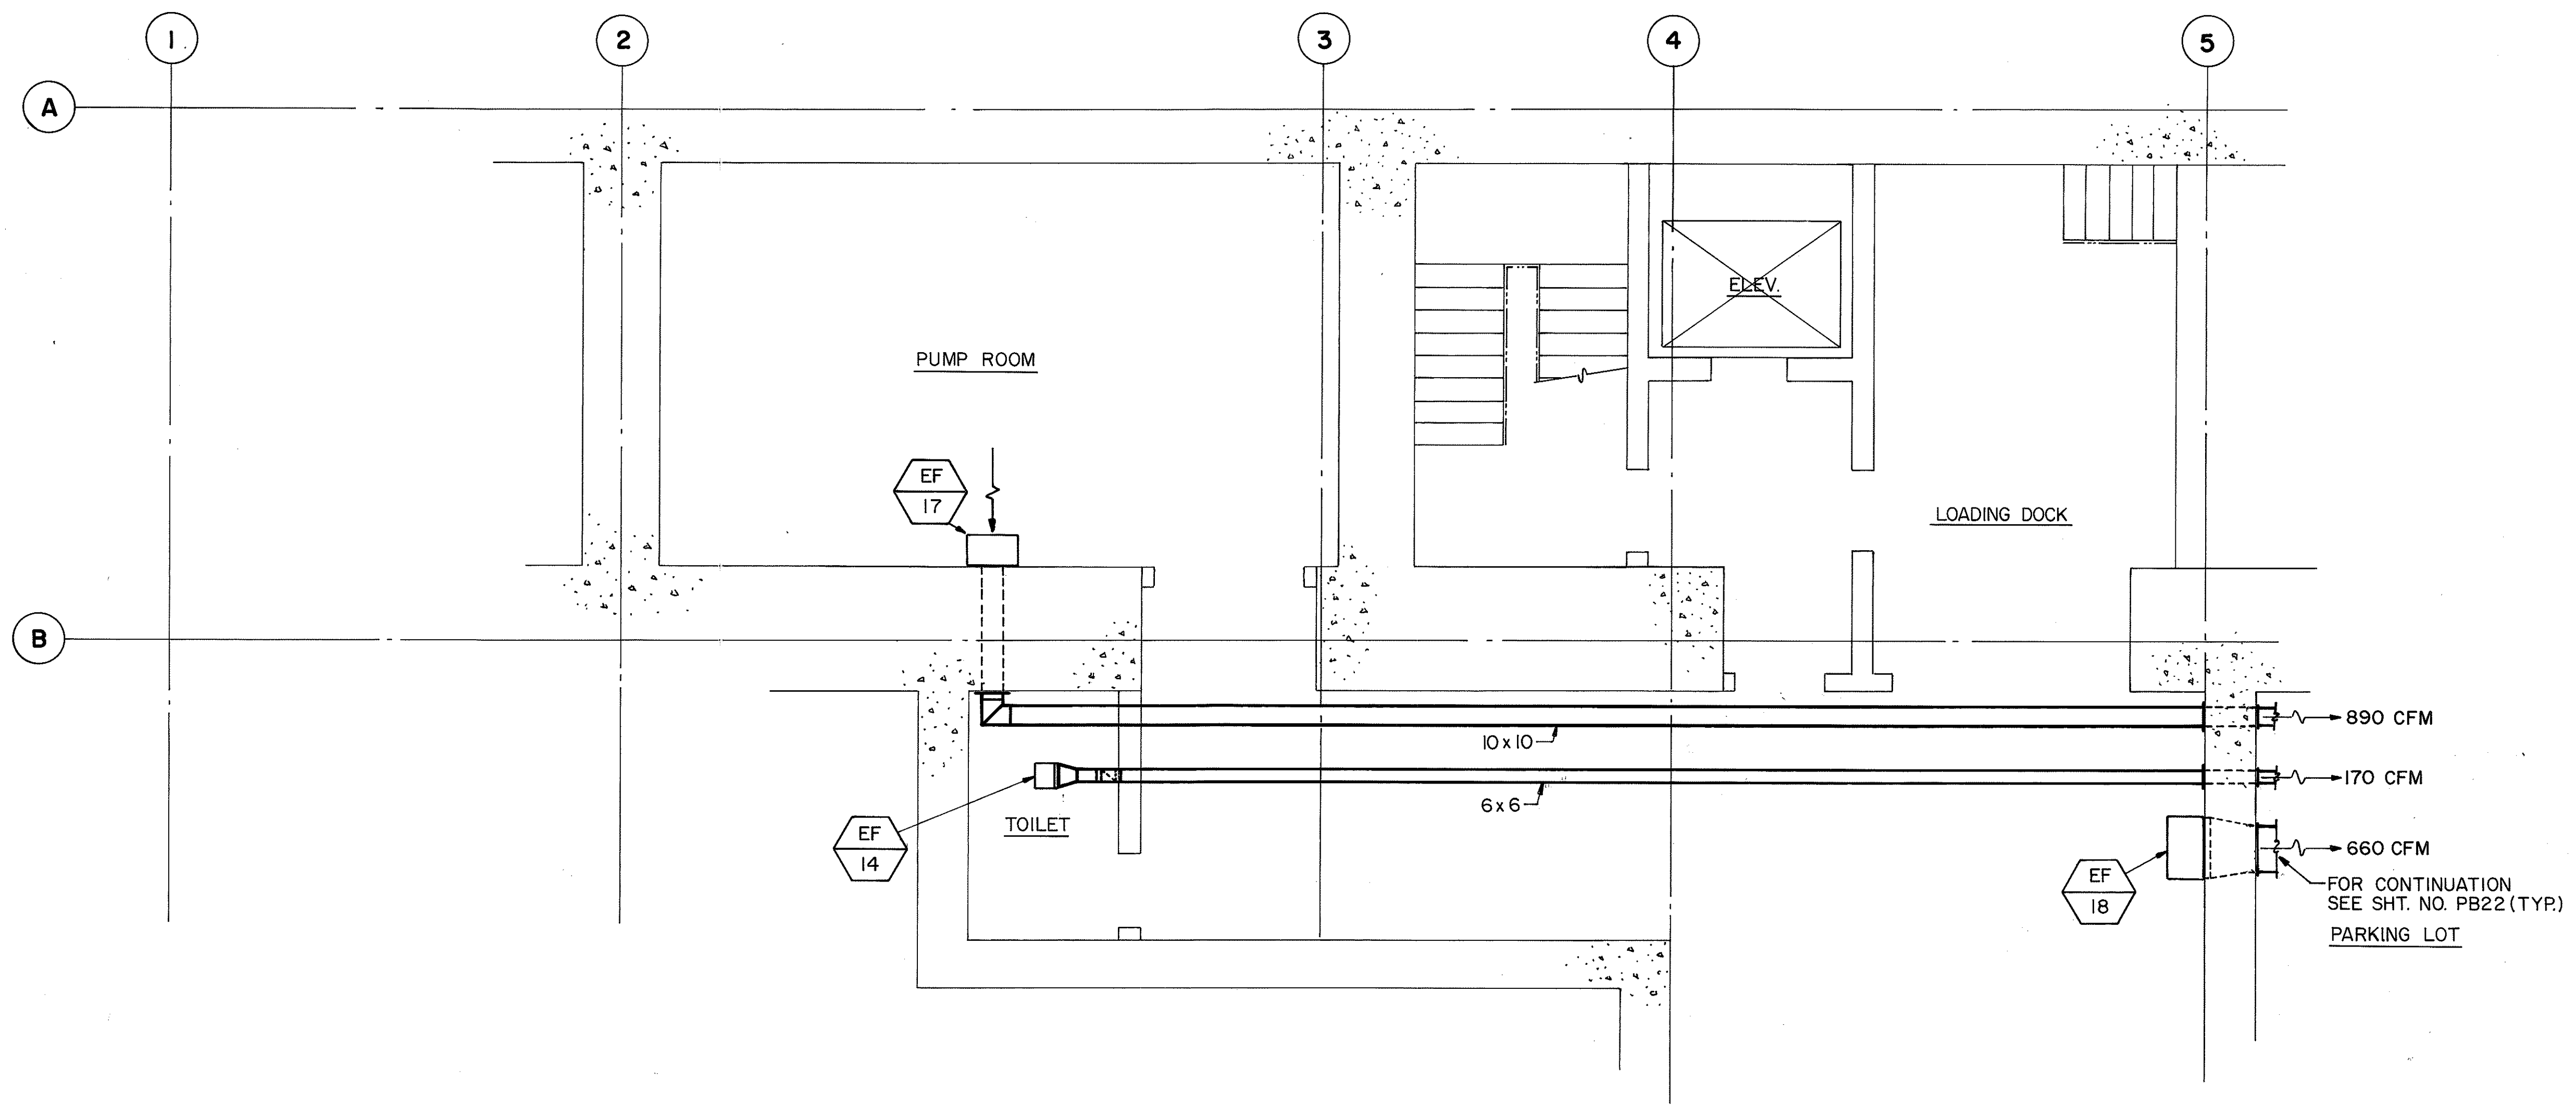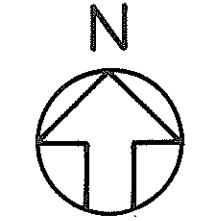

LEVEL A PARTIAL PLAN

ORIGINAL PLAN	DATE
NO.	3/12/89
DESIGNED BY	3/20/89
CHECKED BY	6/08/90
DRAWN BY	
NOTED BY	
DESIGNED BY	
CHECKED BY	
DRAWN BY	
NOTED BY	

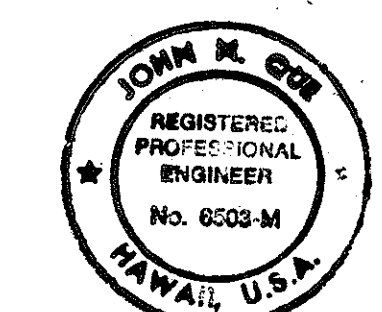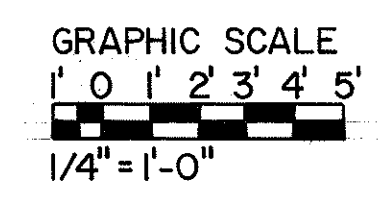

THIS WORK WAS PREPARED BY ME
OR UNDER MY SUPERVISION.
John M. Orr

FOR DETAIL AS-BUILT INFORMATION
REFER TO CONSTRUCTION SUBMITTALS


STATE OF HAWAII
DEPARTMENT OF TRANSPORTATION
HIGHWAYS DIVISION

**HVAC - LEVEL A
PARTIAL PLAN**


HAIKU PORTAL BUILDING - OB
INTERSTATE ROUTE H-3
F.A.I. PROJ. NO. I-H3-1(66)

SCALE: 1/4" = 1'-0" DATE: APR 1992
SHEET NO. MQ 1 OF 9 SHEETS


FED. ROAD DIST. NO.	STATE	FED. AID PROJ. NO.	FISCAL YEAR	SHEET NO.	TOTAL SHEETS
HAWAII	HAW.	I- H3-1 (66)	1992	87	440

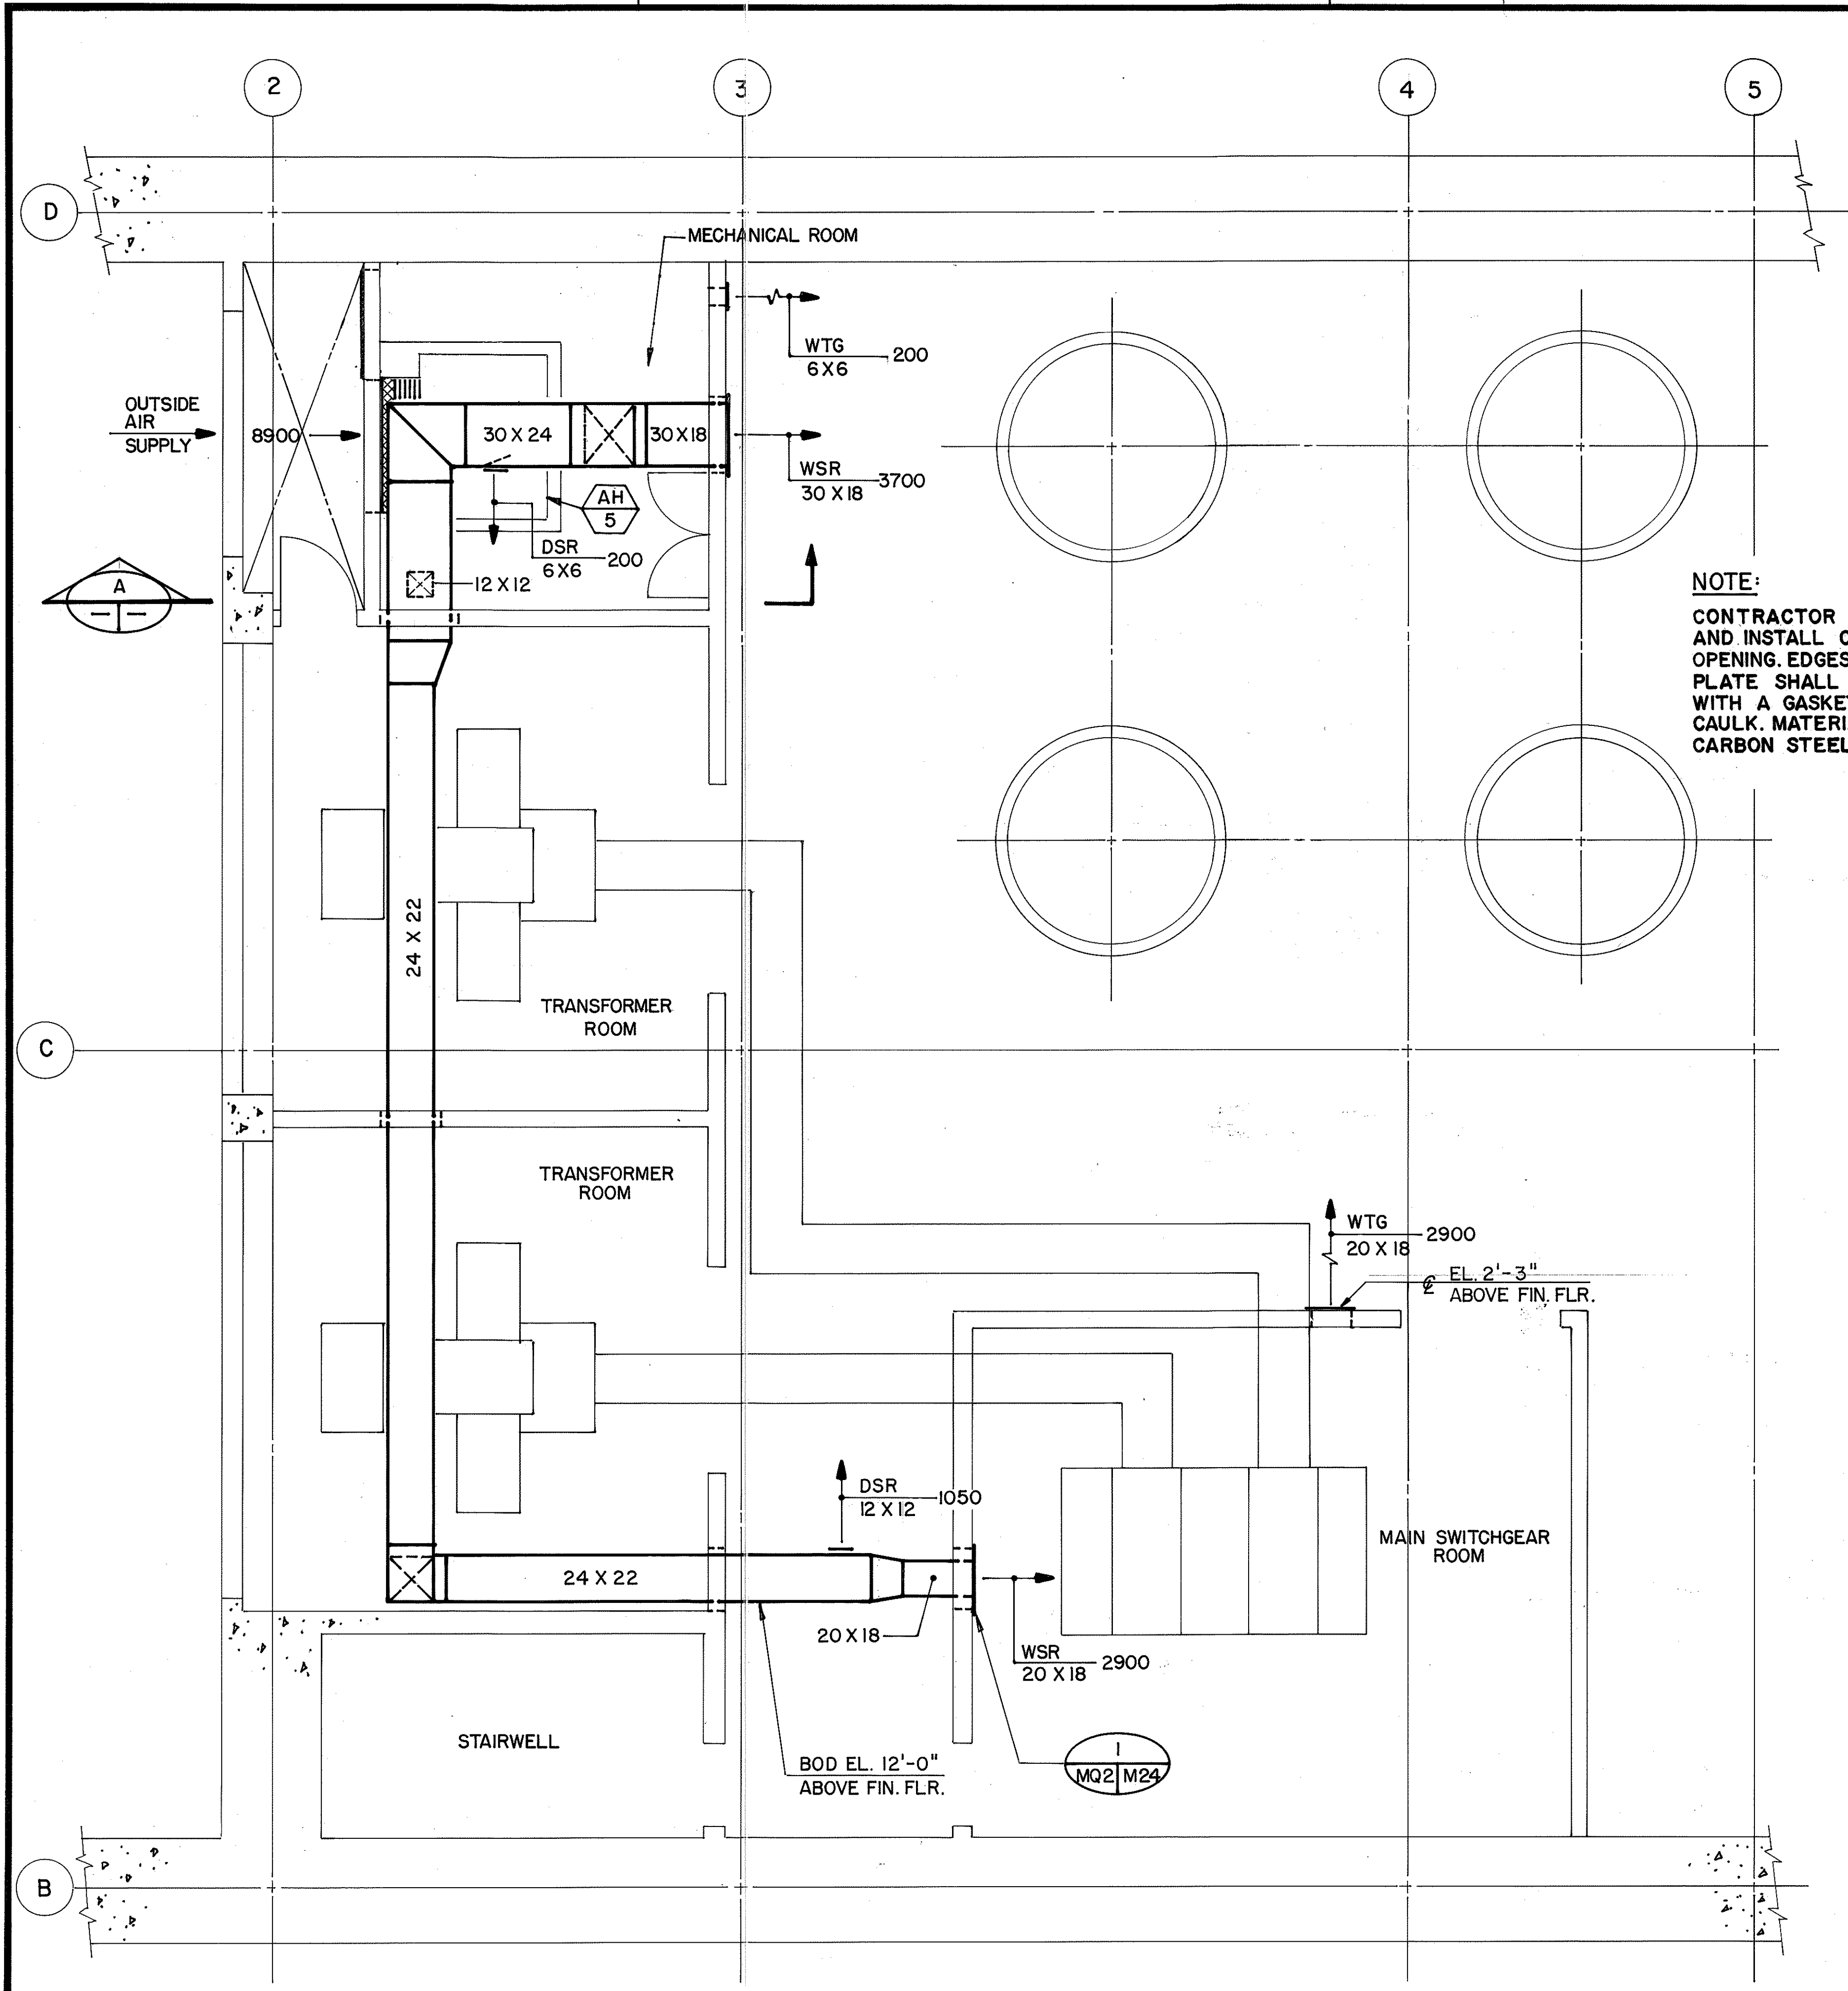

NOTE:
CONTRACTOR SHALL PROVIDE AND INSTALL CLOSURE FOR OPENING EDGES OF CLOSURE PLATE SHALL BE SEALED WITH A GASKET MATERIAL OR CAULK. MATERIAL SHALL BE CARBON STEEL, GALVANIZED.

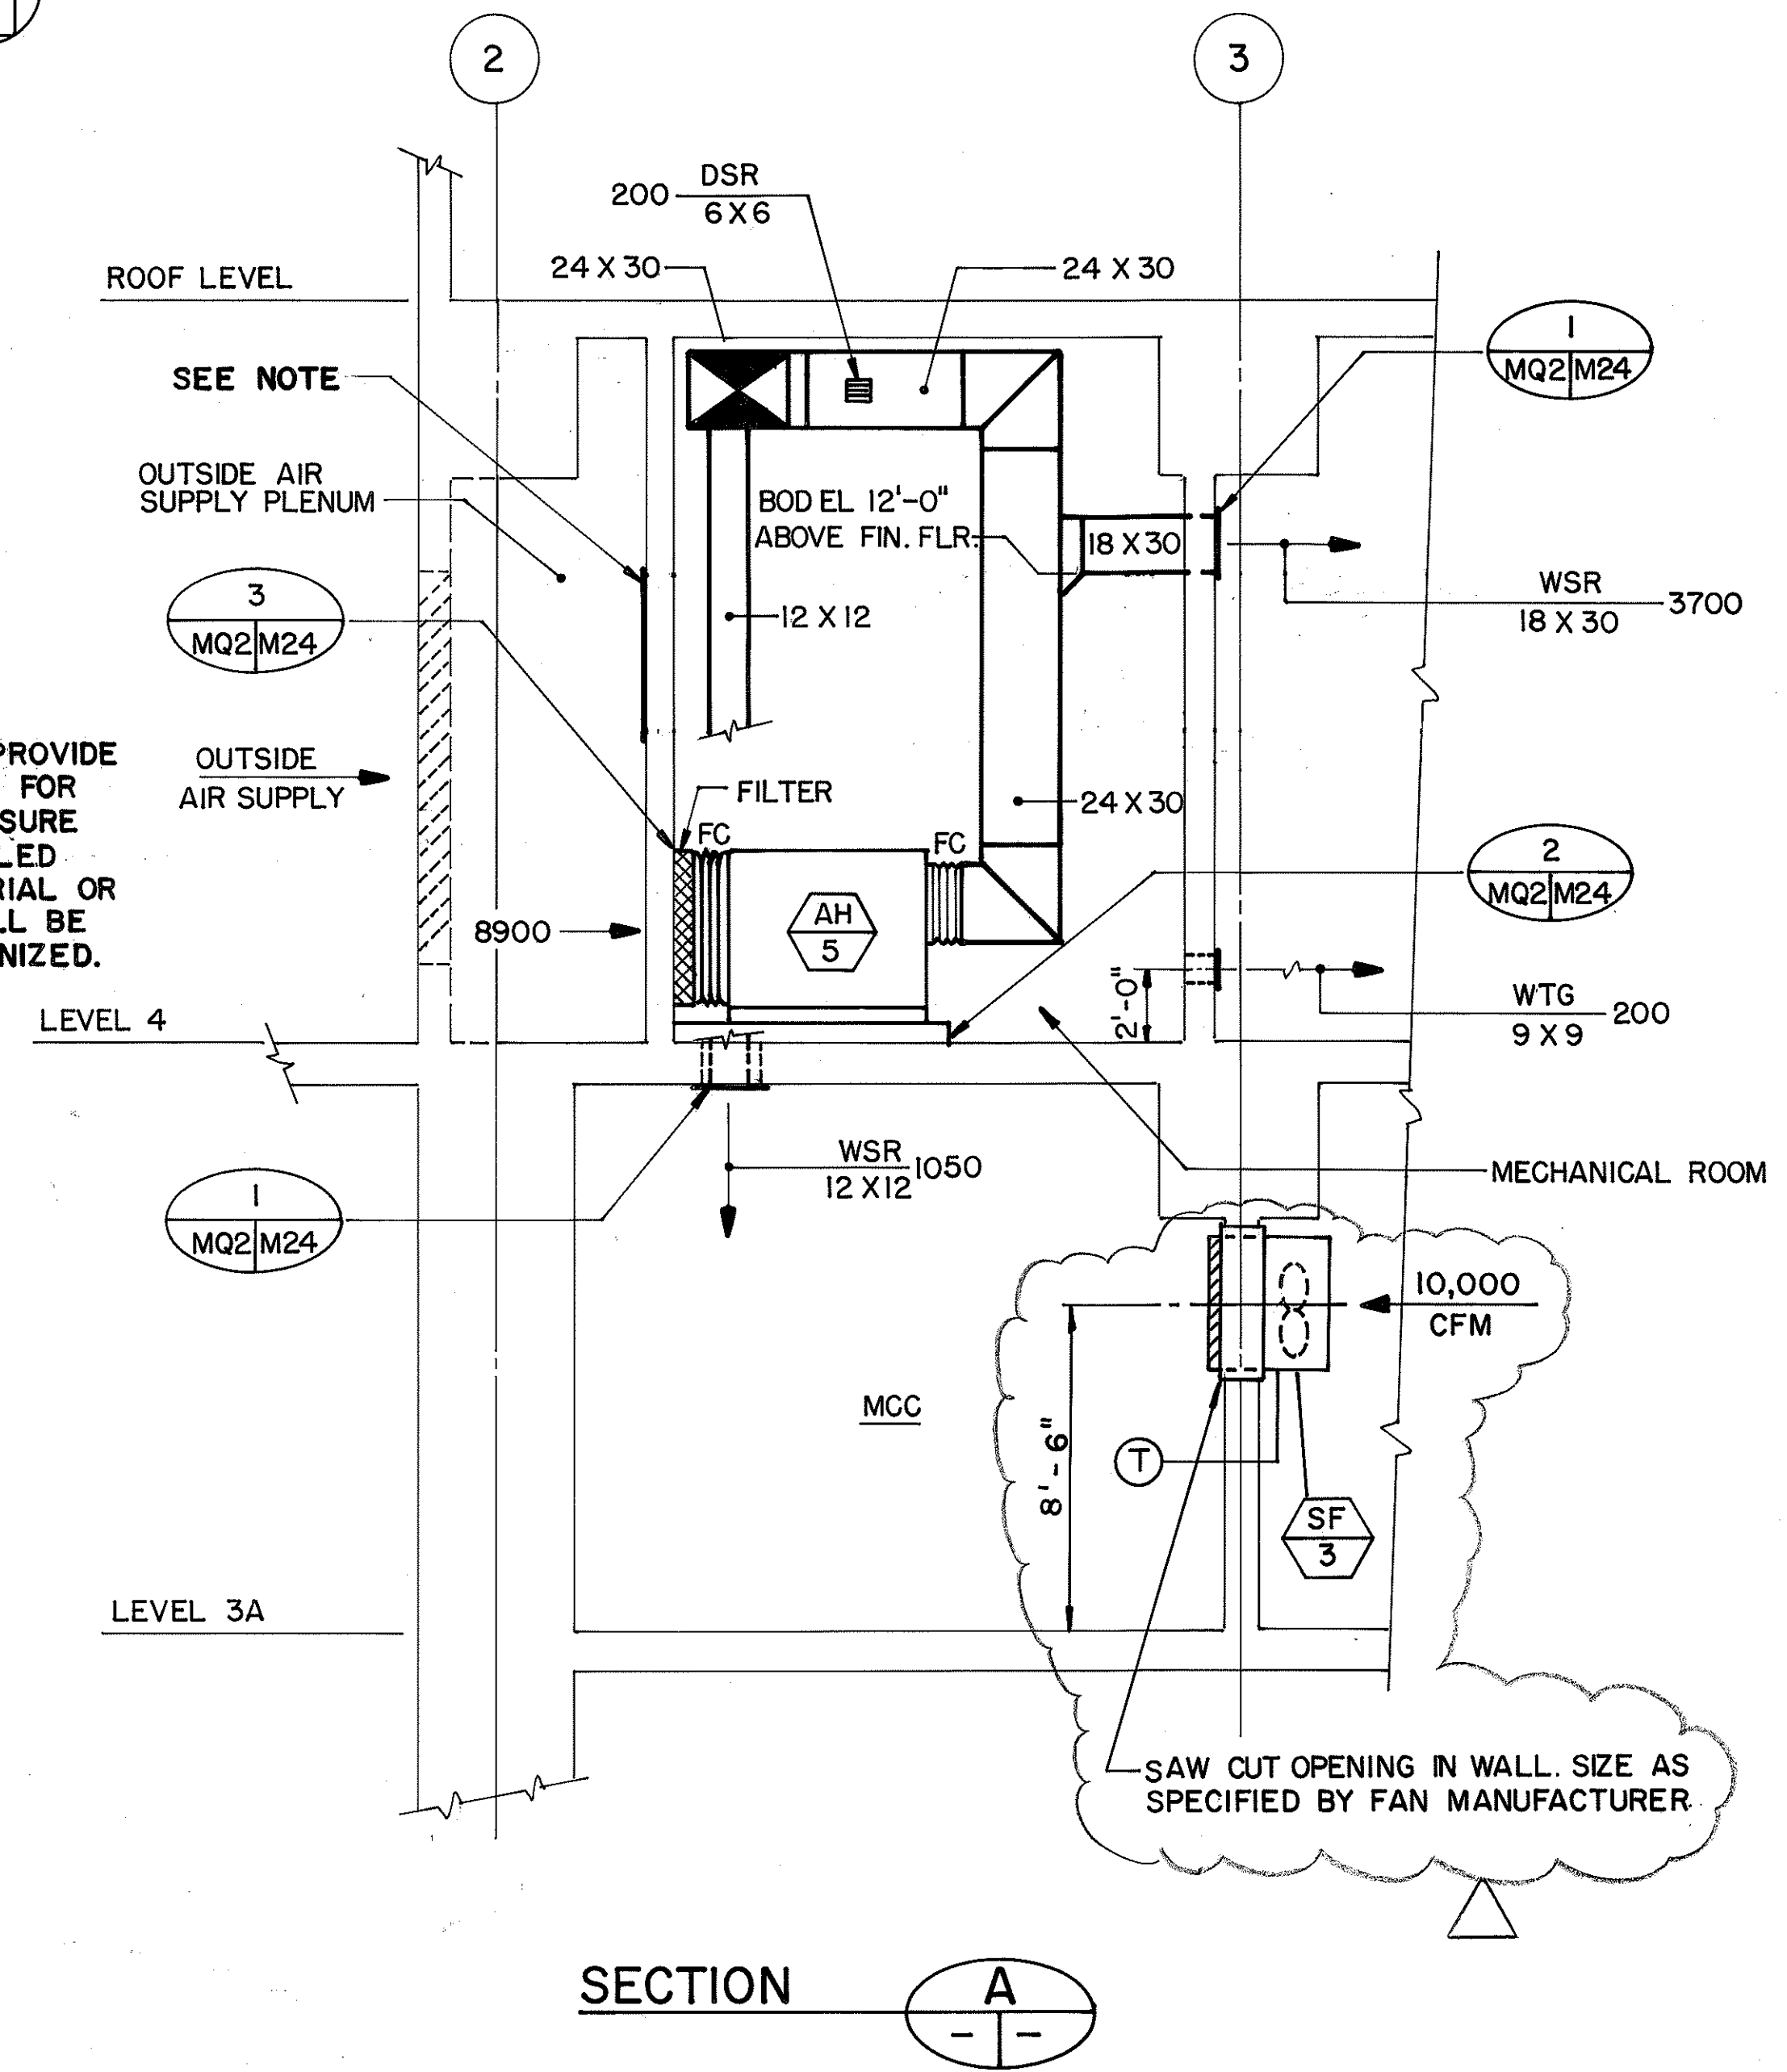

ORIGINAL PLAN	SURVEY PLOTTED BY	DATE
NOTE BOOK	B. BUNYI	11/14/89
	DESIGNED BY	0/23/89
	D. E. DRYDEN	
	CHECKED BY	6/05/90
	J. N. QUE	

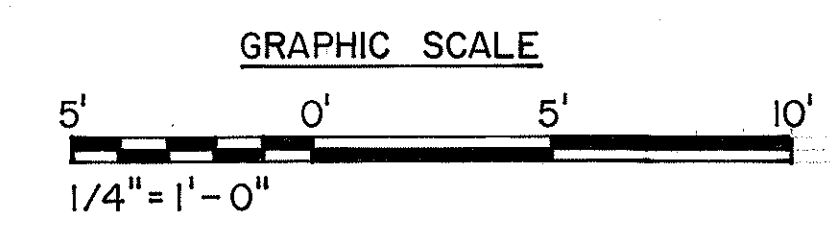

JOHN N. QUE
REGISTERED PROFESSIONAL ENGINEER
No. 6503-M
HAWAII, U.S.A.

THIS WORK WAS PREPARED BY ME OR UNDER MY SUPERVISION


John N. Que

3/8/94	REV. SECT. 'A', ADDED SF PER DCN 66-039
5/13/93	DELETED AUX. COOLING FANS & ASSOC. DUCTWORK PER DCN 66-004
DATE	REVISION


STATE OF HAWAII DEPARTMENT OF TRANSPORTATION HIGHWAYS DIVISION
HVAC — LEVEL 4
PARTIAL PLAN AND SECTION
HAIKU PORTAL BUILDING - OB
INTERSTATE ROUTE H-3
F.A.I. PROJ. NO. I- H3-1(66)
SCALE: 1/4" = 1'-0" DATE: APR 1992
SHEET NO. MQ2 OF 9 SHEETS

FED. ROAD DIST. NO.	STATE	FED. AID PROJ. NO.	FISCAL YEAR	SHEET NO.	TOTAL SHEETS
HAWAII	HAW.	I-H3-1(66)	1992	88	440


NOTE
FOR SAWCUT OPENINGS—BUSH HAMMER EXPOSED EDGES TO EVEN SURFACE, GRIND SMOOTH. PAINT EDGES OF OPENINGS AND EXPOSED REBAR WITH EPOXY PAINT.

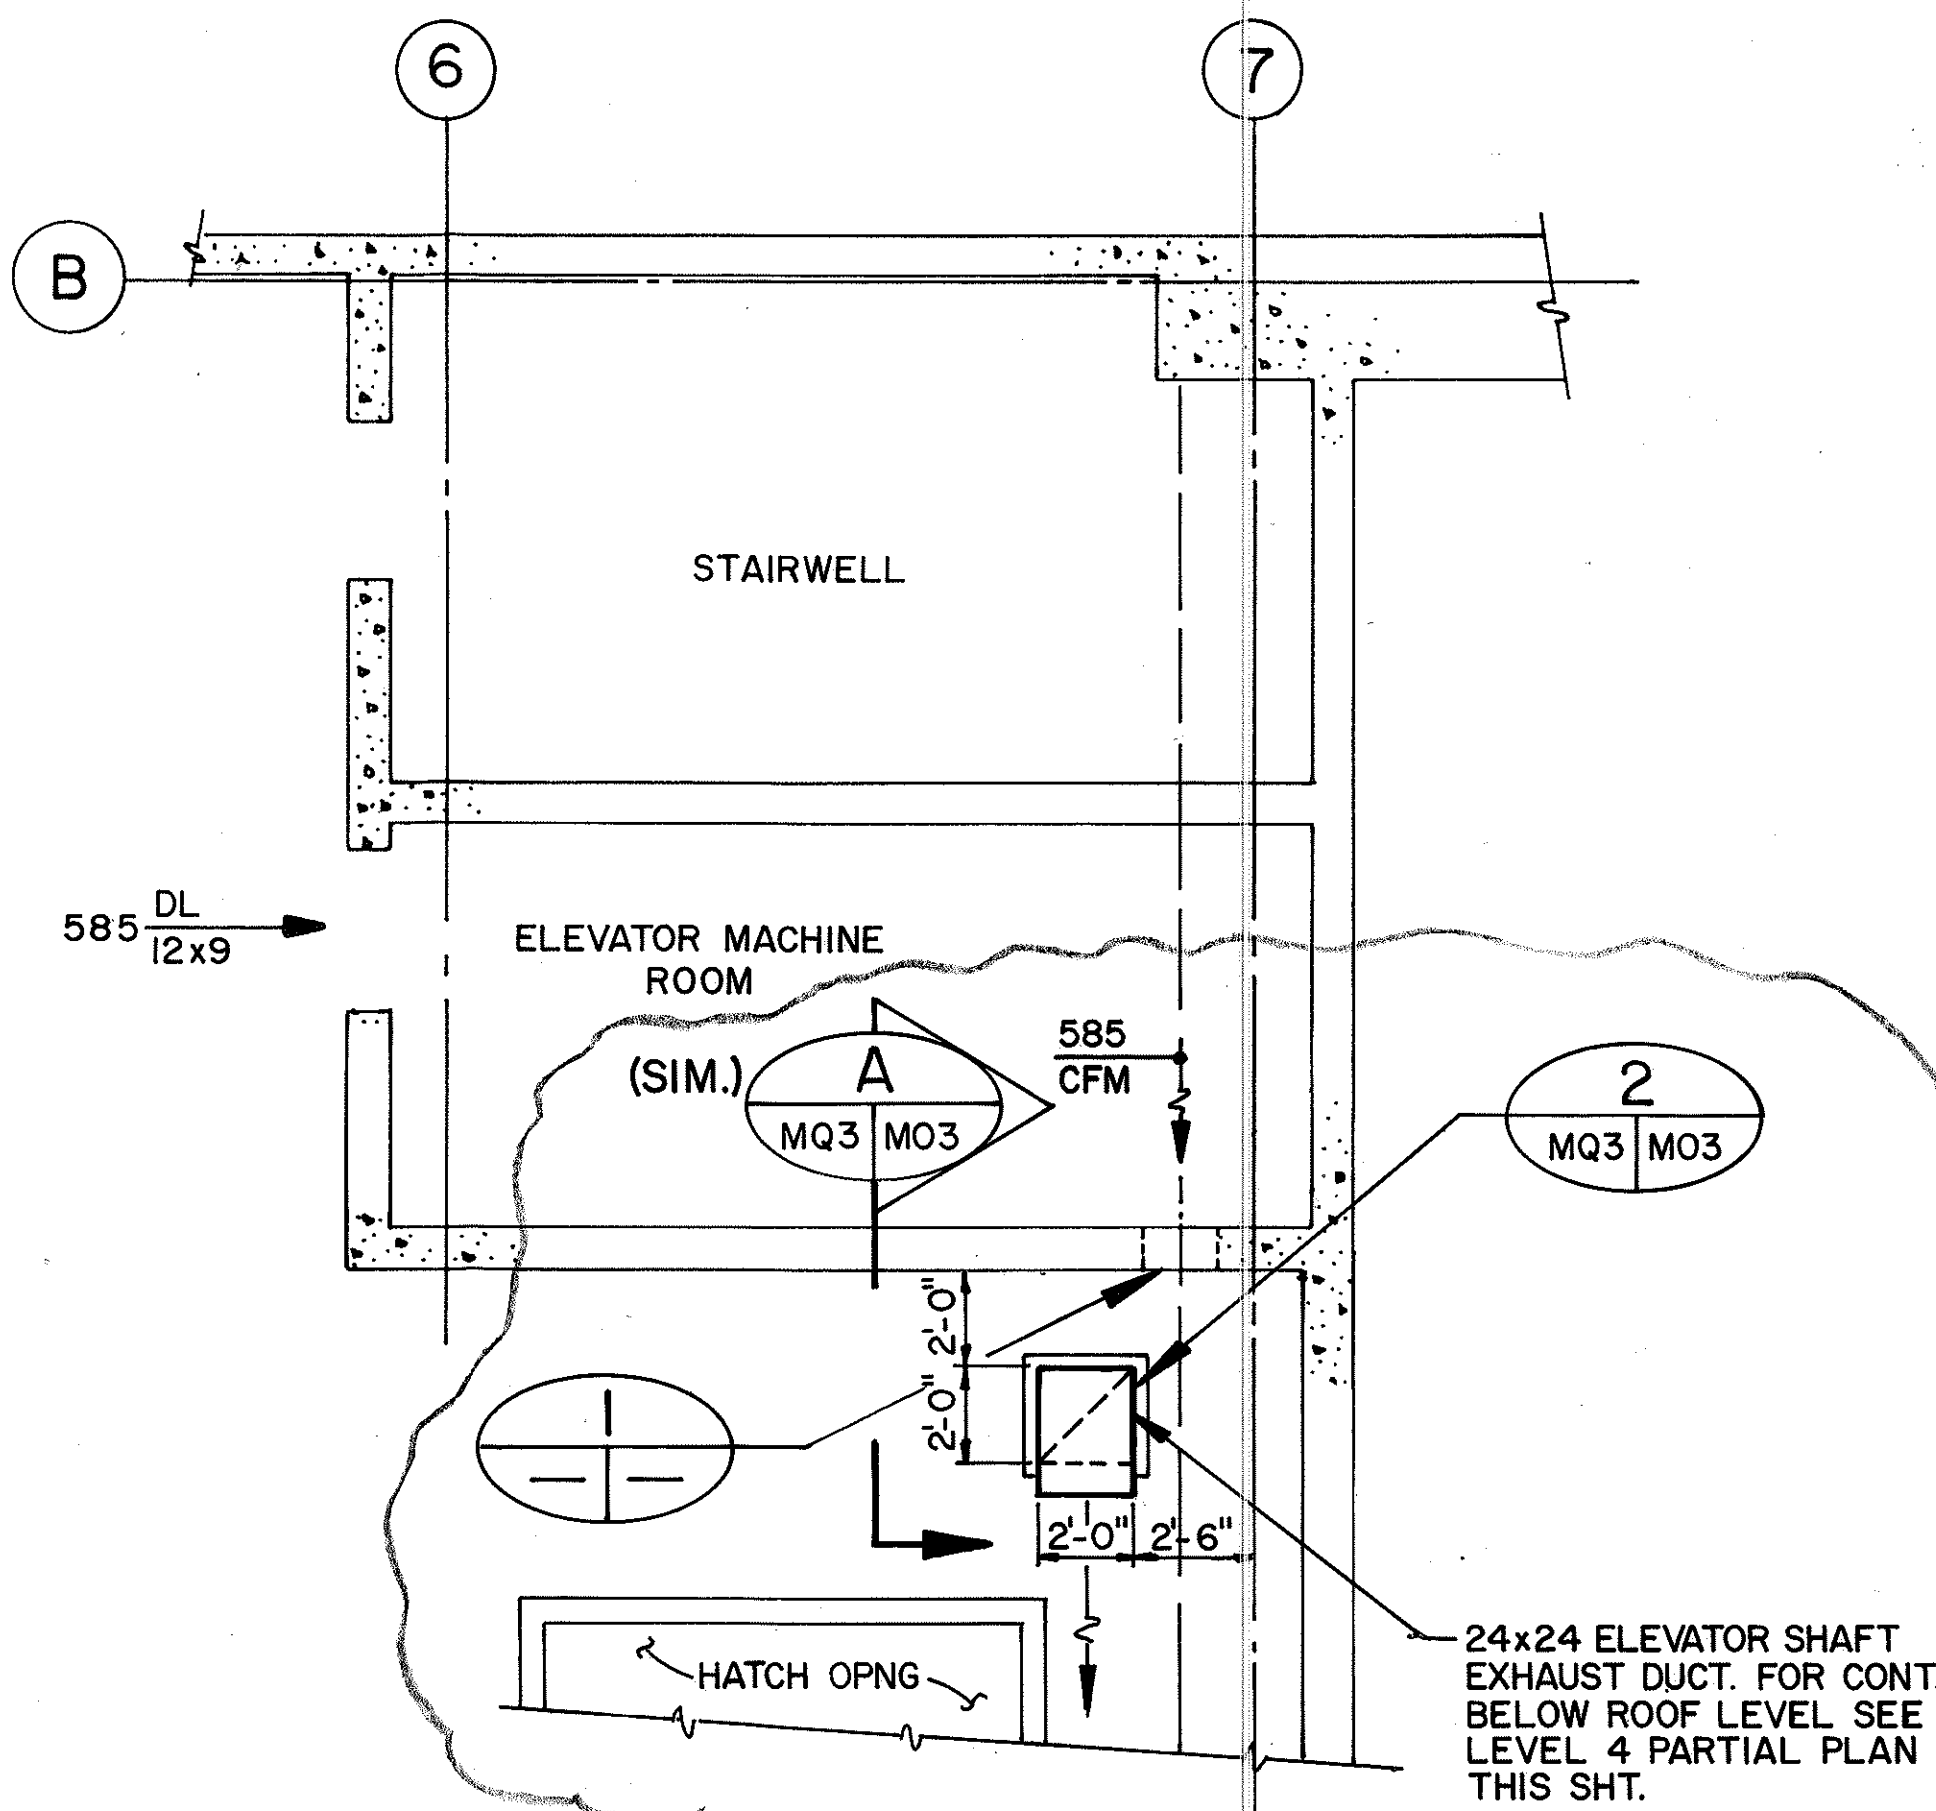


ROOF LEVEL PARTIAL PLAN
SCALE: 1/4"=1'-0"

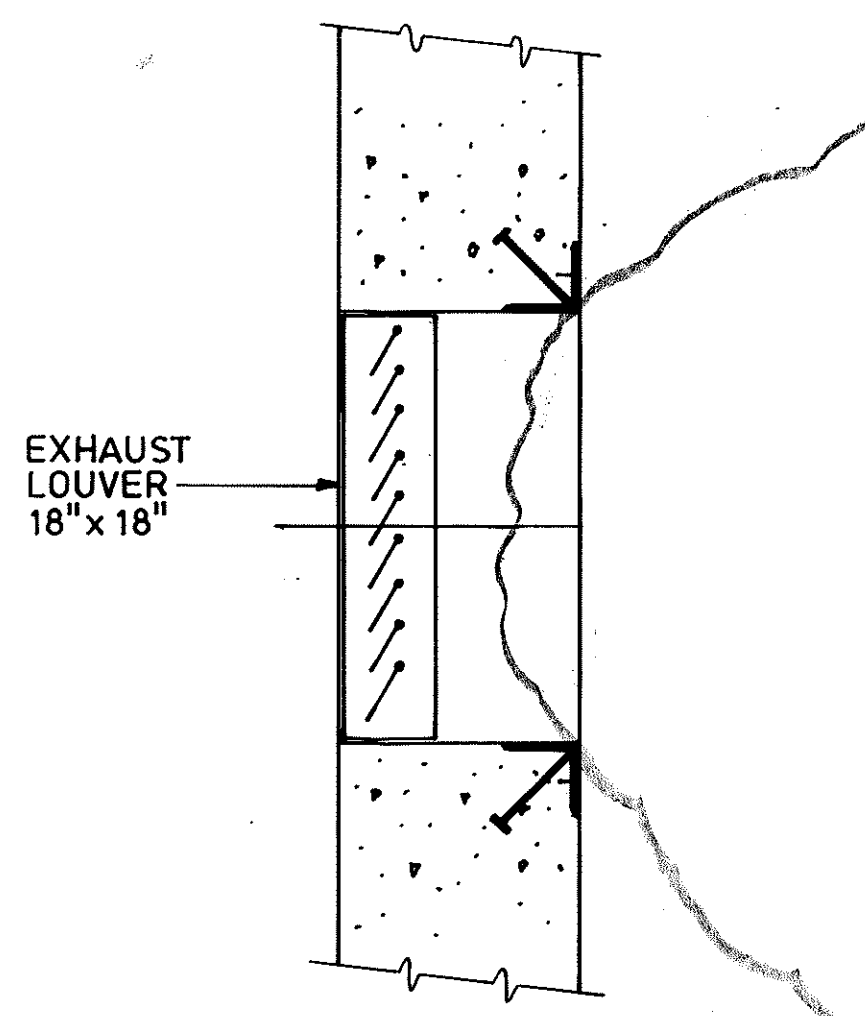


DETAIL
NO SCALE

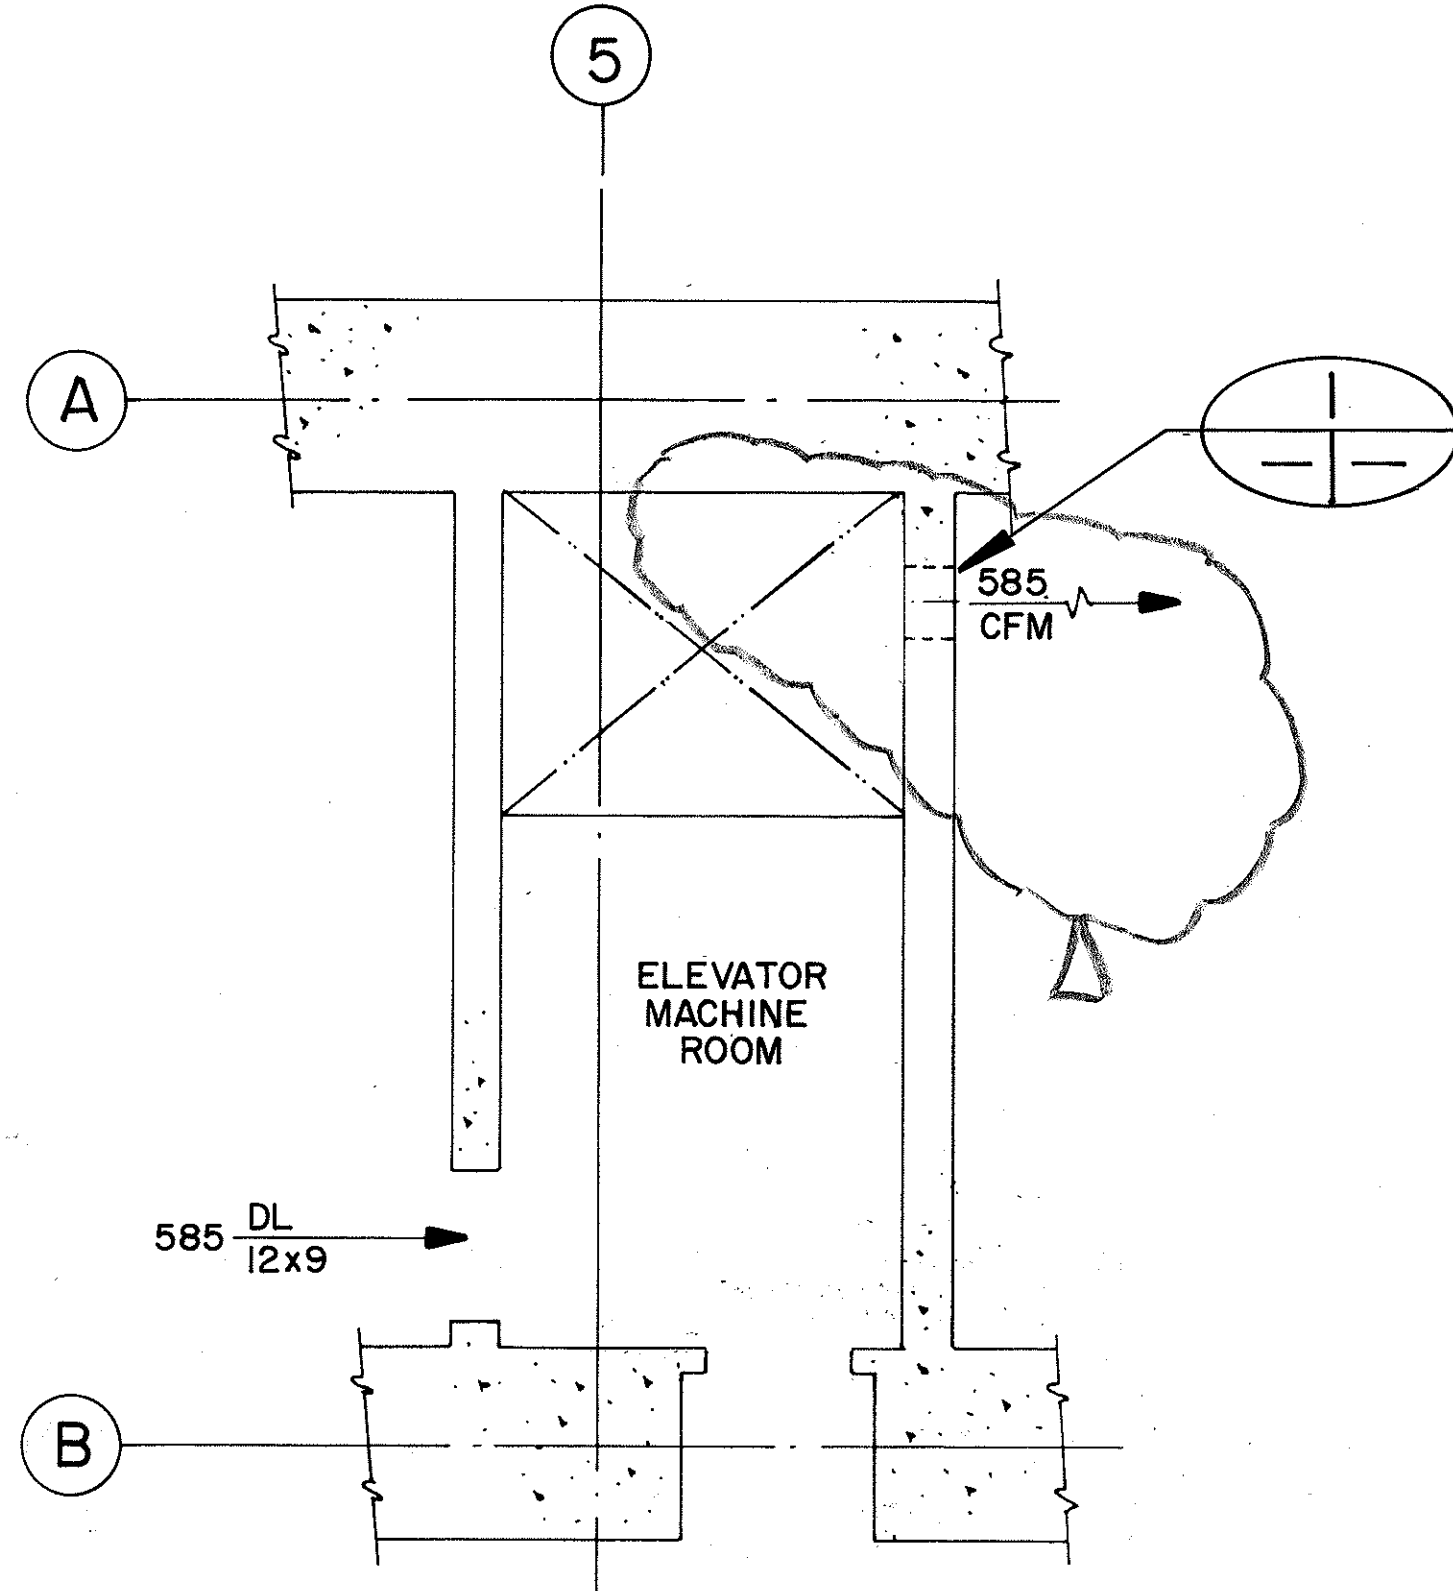



LEVEL 3 PARTIAL PLAN
SCALE: 1/4"=1'-0"

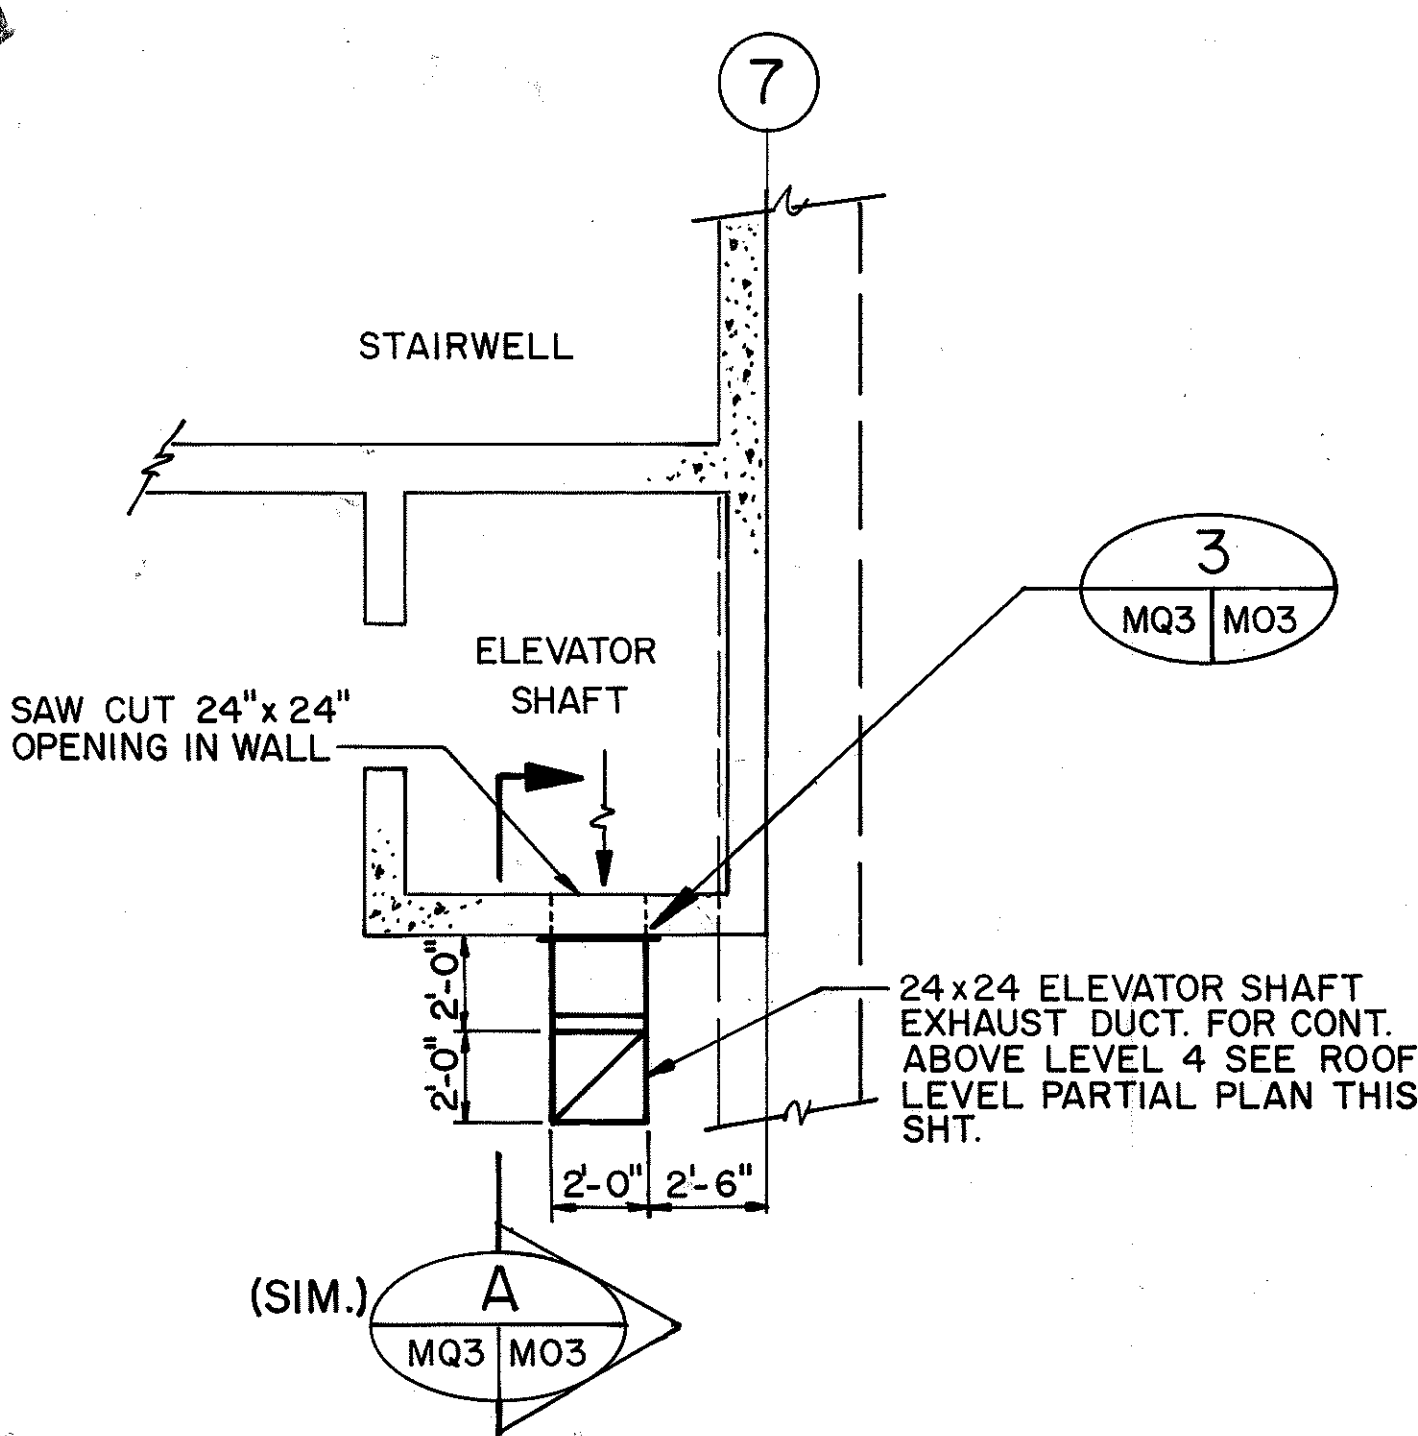

LEVEL 4 PARTIAL PLAN
SCALE: 1/4"=1'-0"

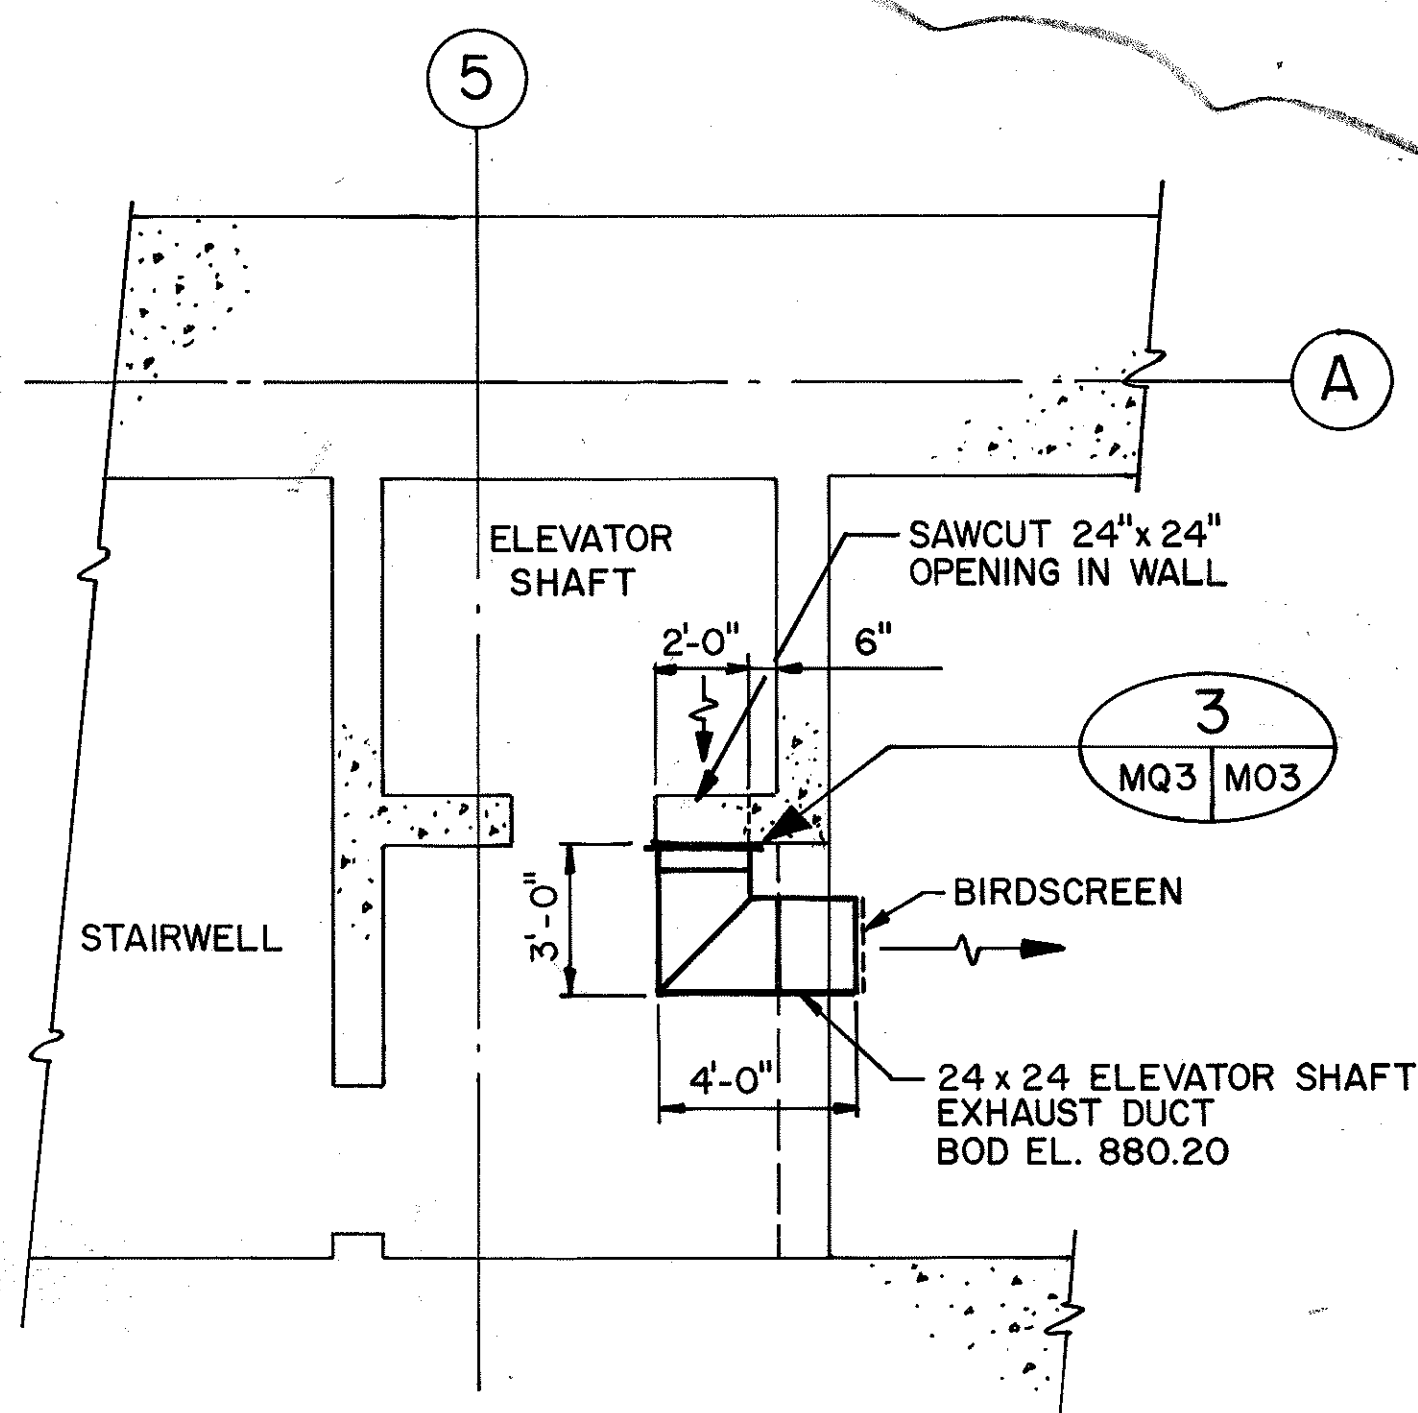

LEVEL 2 PARTIAL PLAN
SCALE: 1/4"=1'-0"

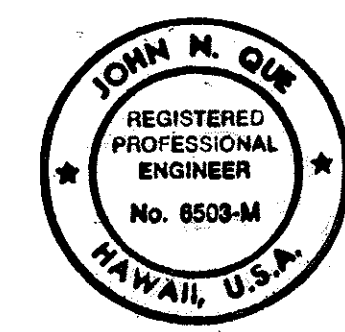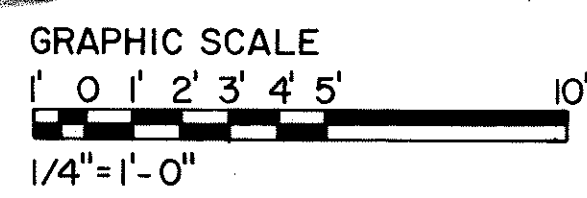



THIS WORK WAS PREPARED BY ME OR UNDER MY SUPERVISION

DATE	REVISION
9/14/94	REV. PER DCN 66-052

STATE OF HAWAII
DEPARTMENT OF TRANSPORTATION
HIGHWAYS DIVISION
**HVAC-ELEVATOR EQUIPMENT
ROOMS-PLANS & DETAILS**
HAIKU PORTAL BUILDING-OB
INTERSTATE ROUTE H-3
F.A.I. PROJ. NO. I-H3-1(66)

SCALE: AS NOTED DATE: APR 1992
SHEET NO. MQ3 OF 9 SHEETS

SURVEY DATED BY	DATE
DRAWN BY	1/20/89
DESIGNED BY	1/15/89
QUANTITIES BY	
CHECKED BY	06/05/90

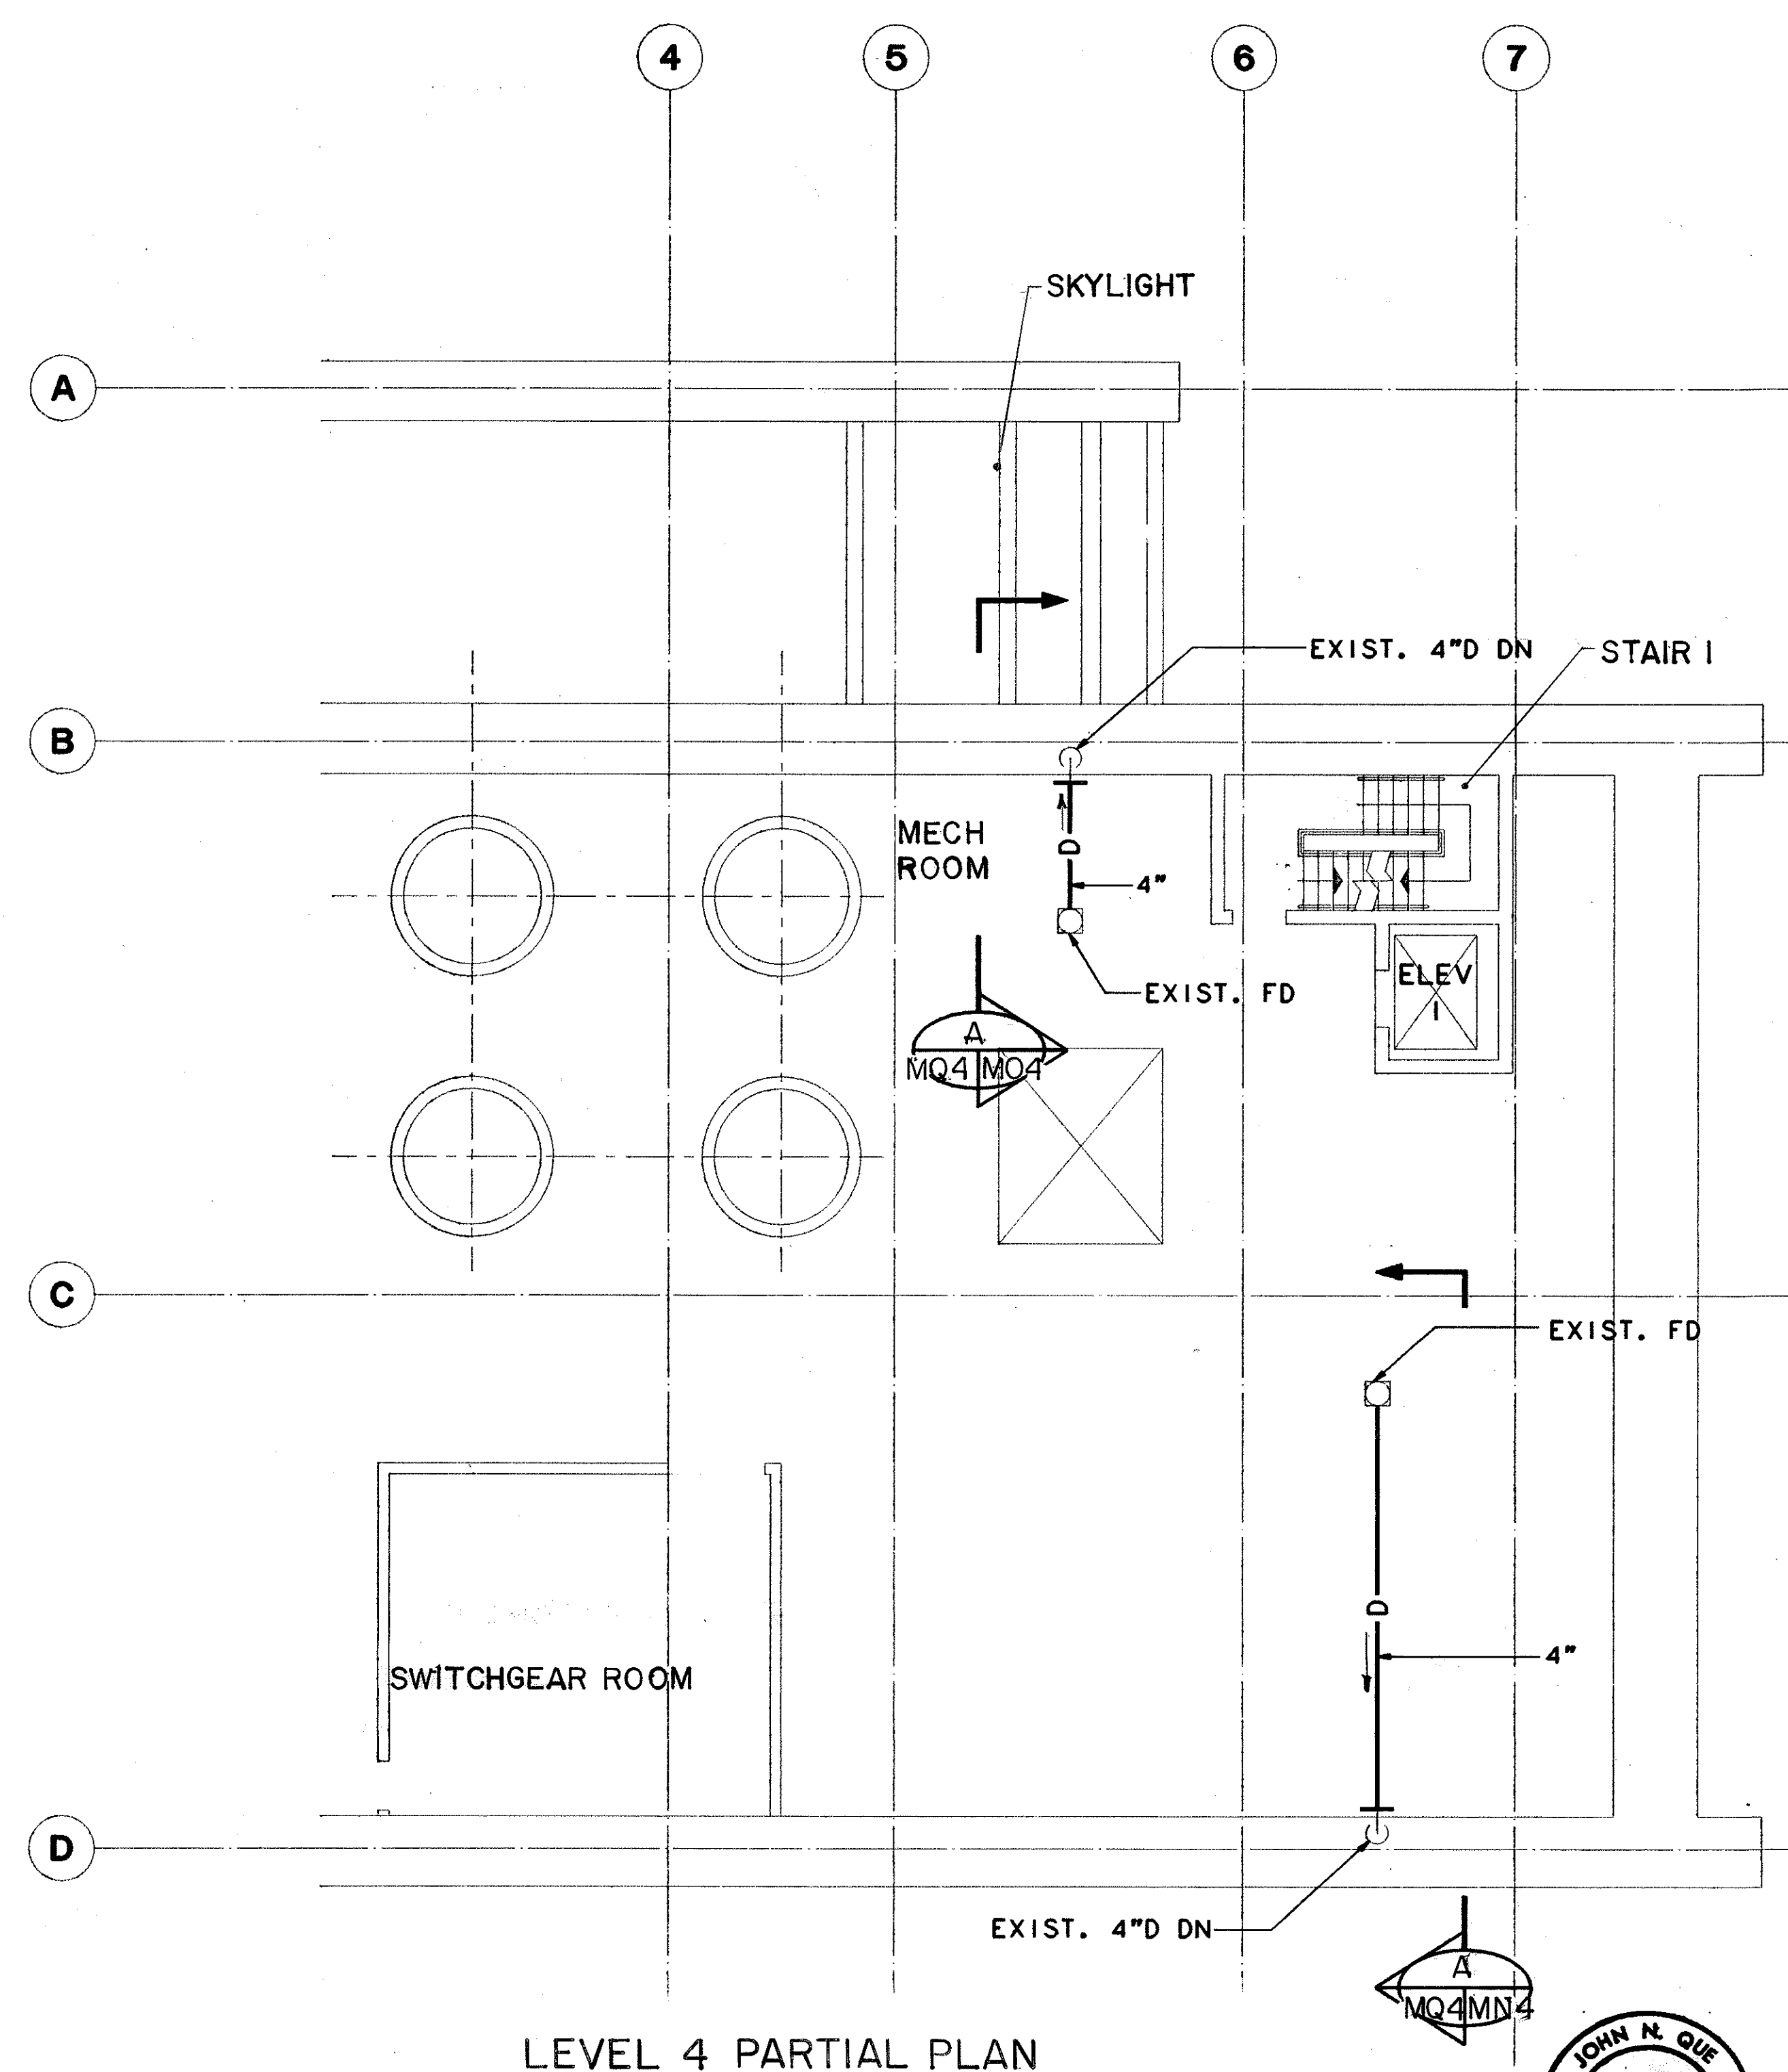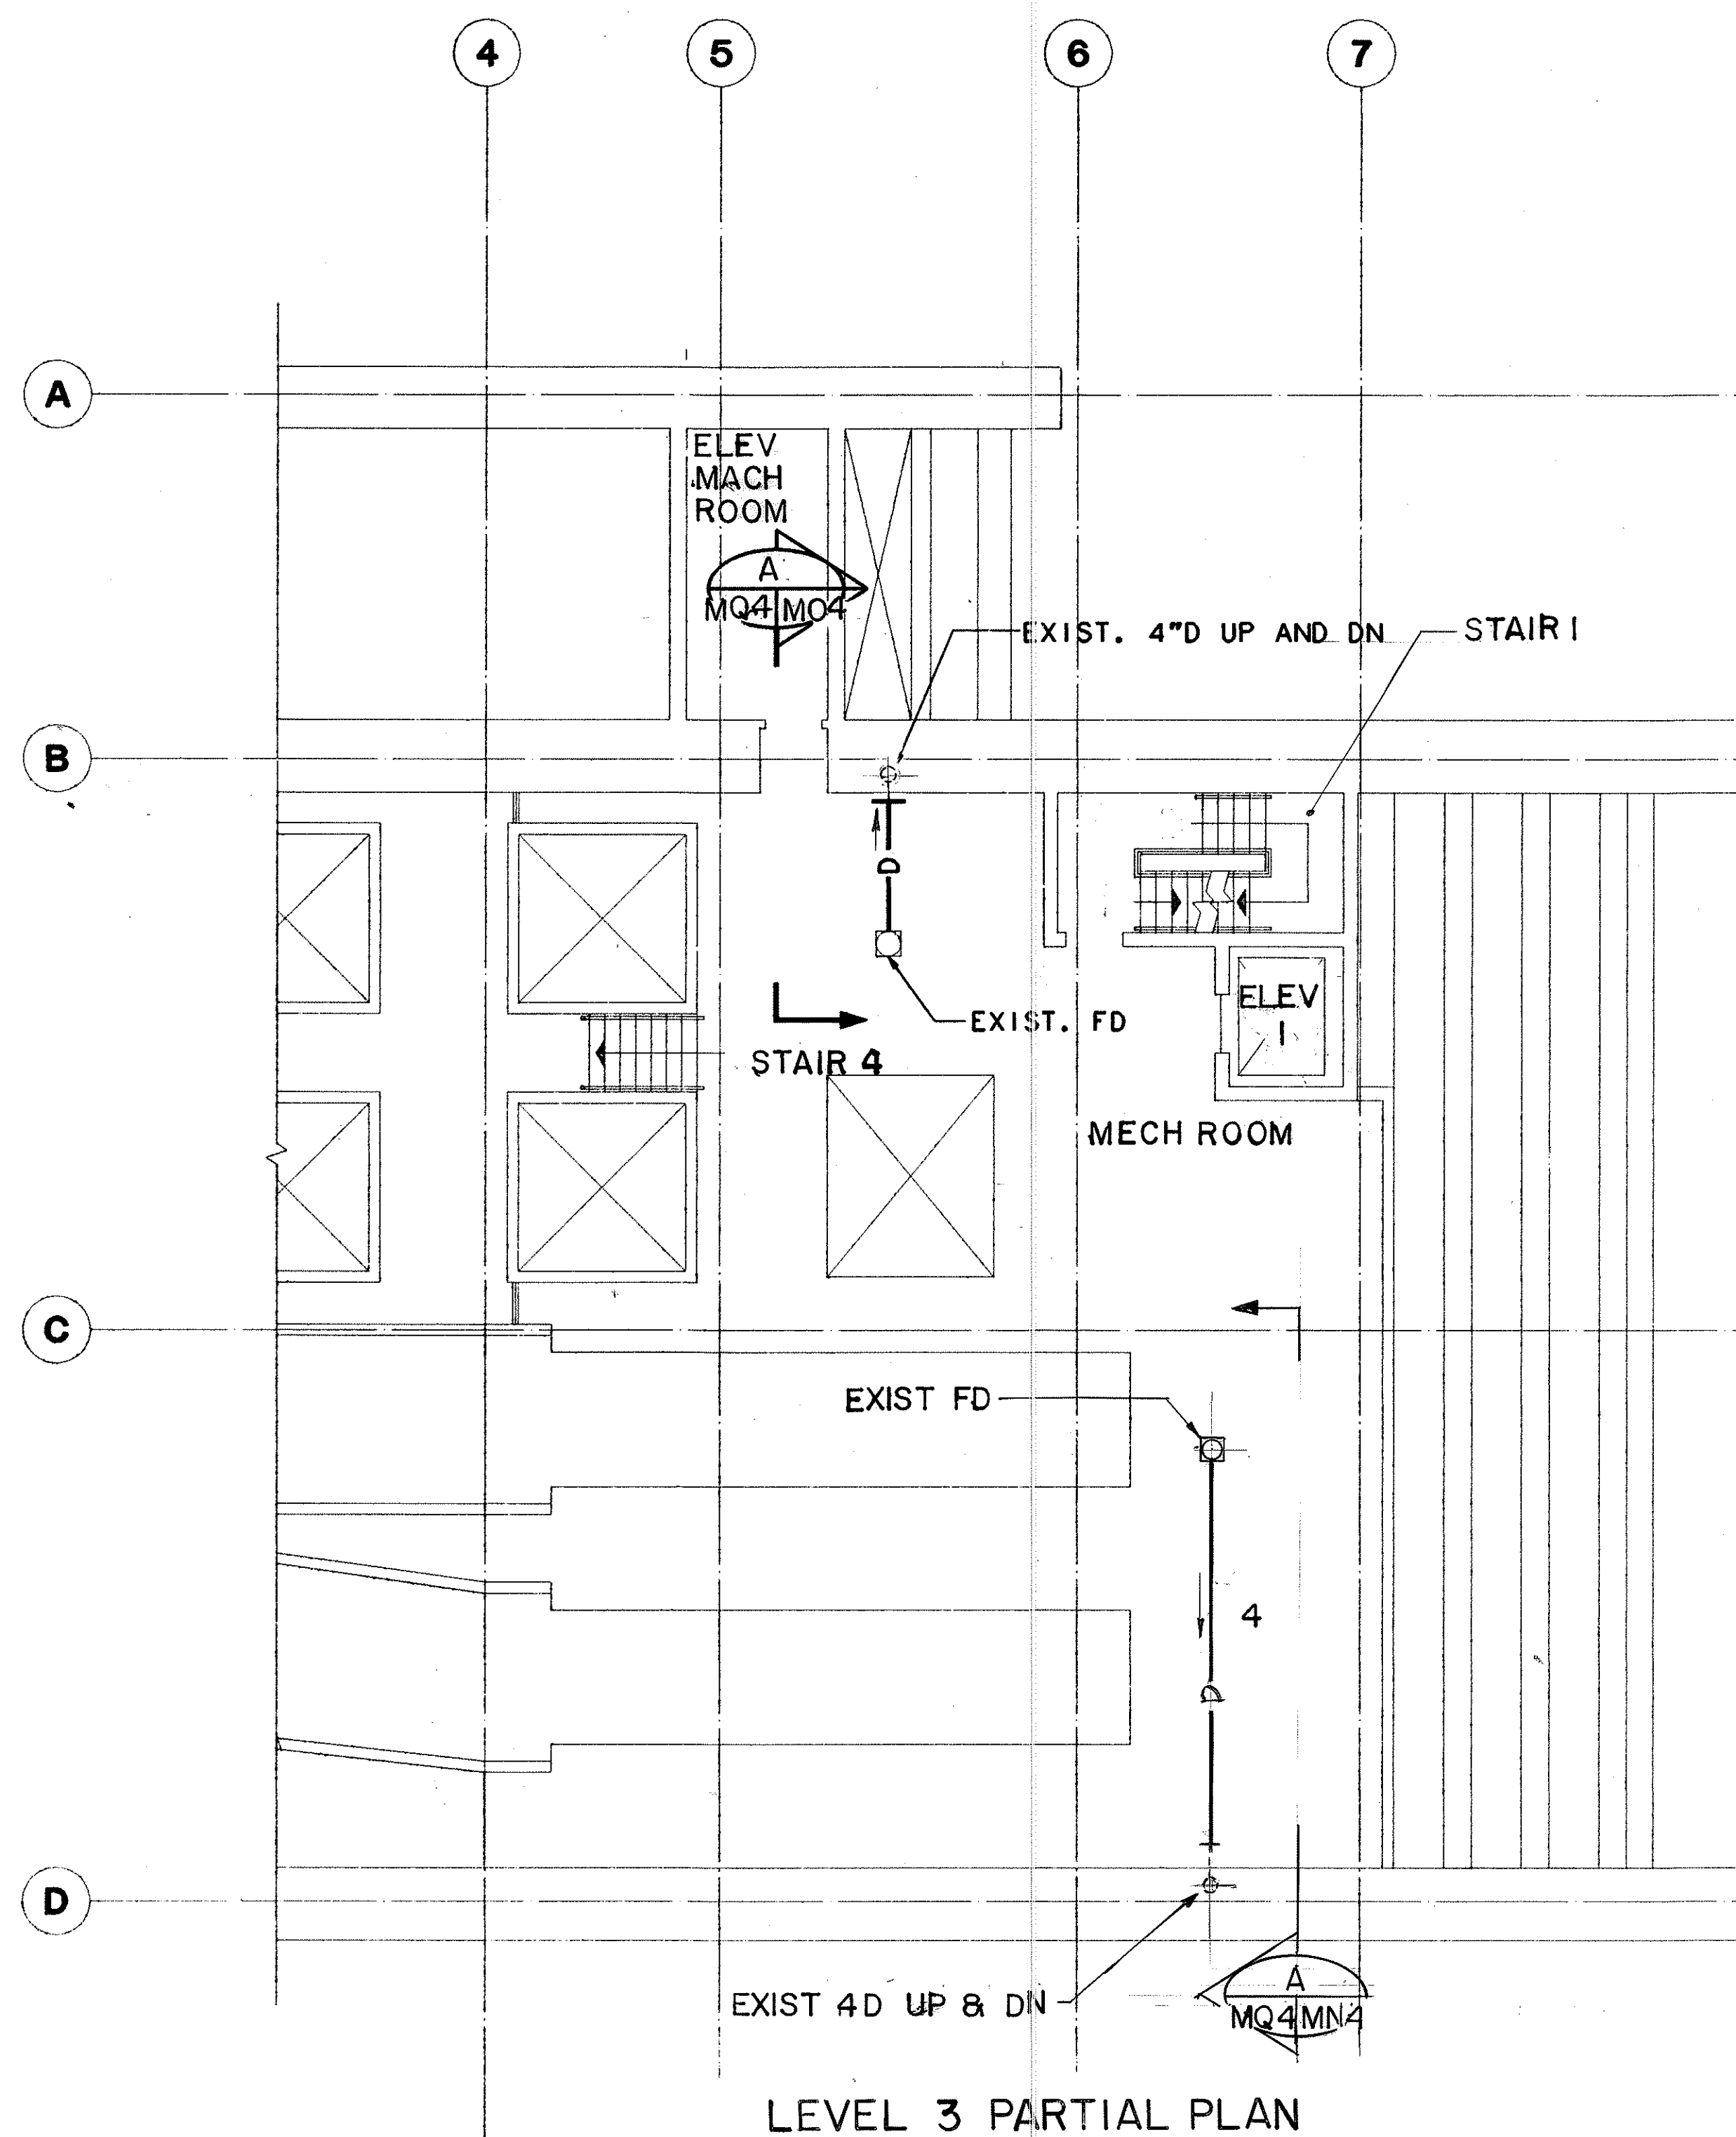

DATE	REVISION
STATE OF HAWAII DEPARTMENT OF TRANSPORTATION HIGHWAYS DIVISION <u>PLUMBING-LEVEL 3 & LEVEL 4 PARTIAL PLANS</u> <u>HAIKU PORTAL BUILDING-OB</u> <u>INTERSTATE ROUTE H-3</u> F.A.I. PROJ. NO. I-H3-I(66)	
SCALE: 1/8" = 1'-0"	
DATE: APR 1992	
SHEET NO. MQ4	OF 9 SHEETS

GRAPHIC SCALE

8' 0' 8' 16'



1/8" = 1'- 0"


JOHN N. QUE
 REGISTERED
 PROFESSIONAL
 ENGINEER
 No. 6503-M
 HAWAII, U.S.A.

THIS WORK WAS PREPARED BY ME
 OR UNDER MY SUPERVISION


[Signature]

ORIGINAL PLAN	SURVEY PLOTTED BY	DATE
	DRAWN BY	
	THRU BY	
NOTE BOOK	DESIGNED BY	
	QUANTITIES BY	
NO.	CHECKED BY	

FED. ROAD DIST. NO.	STATE	FED. AID PROJ. NO.	FISCAL YEAR	SHEET NO.	TOTAL SHEETS
HAWAII	HAW.	I - H3 - I(66)	1992	90	440


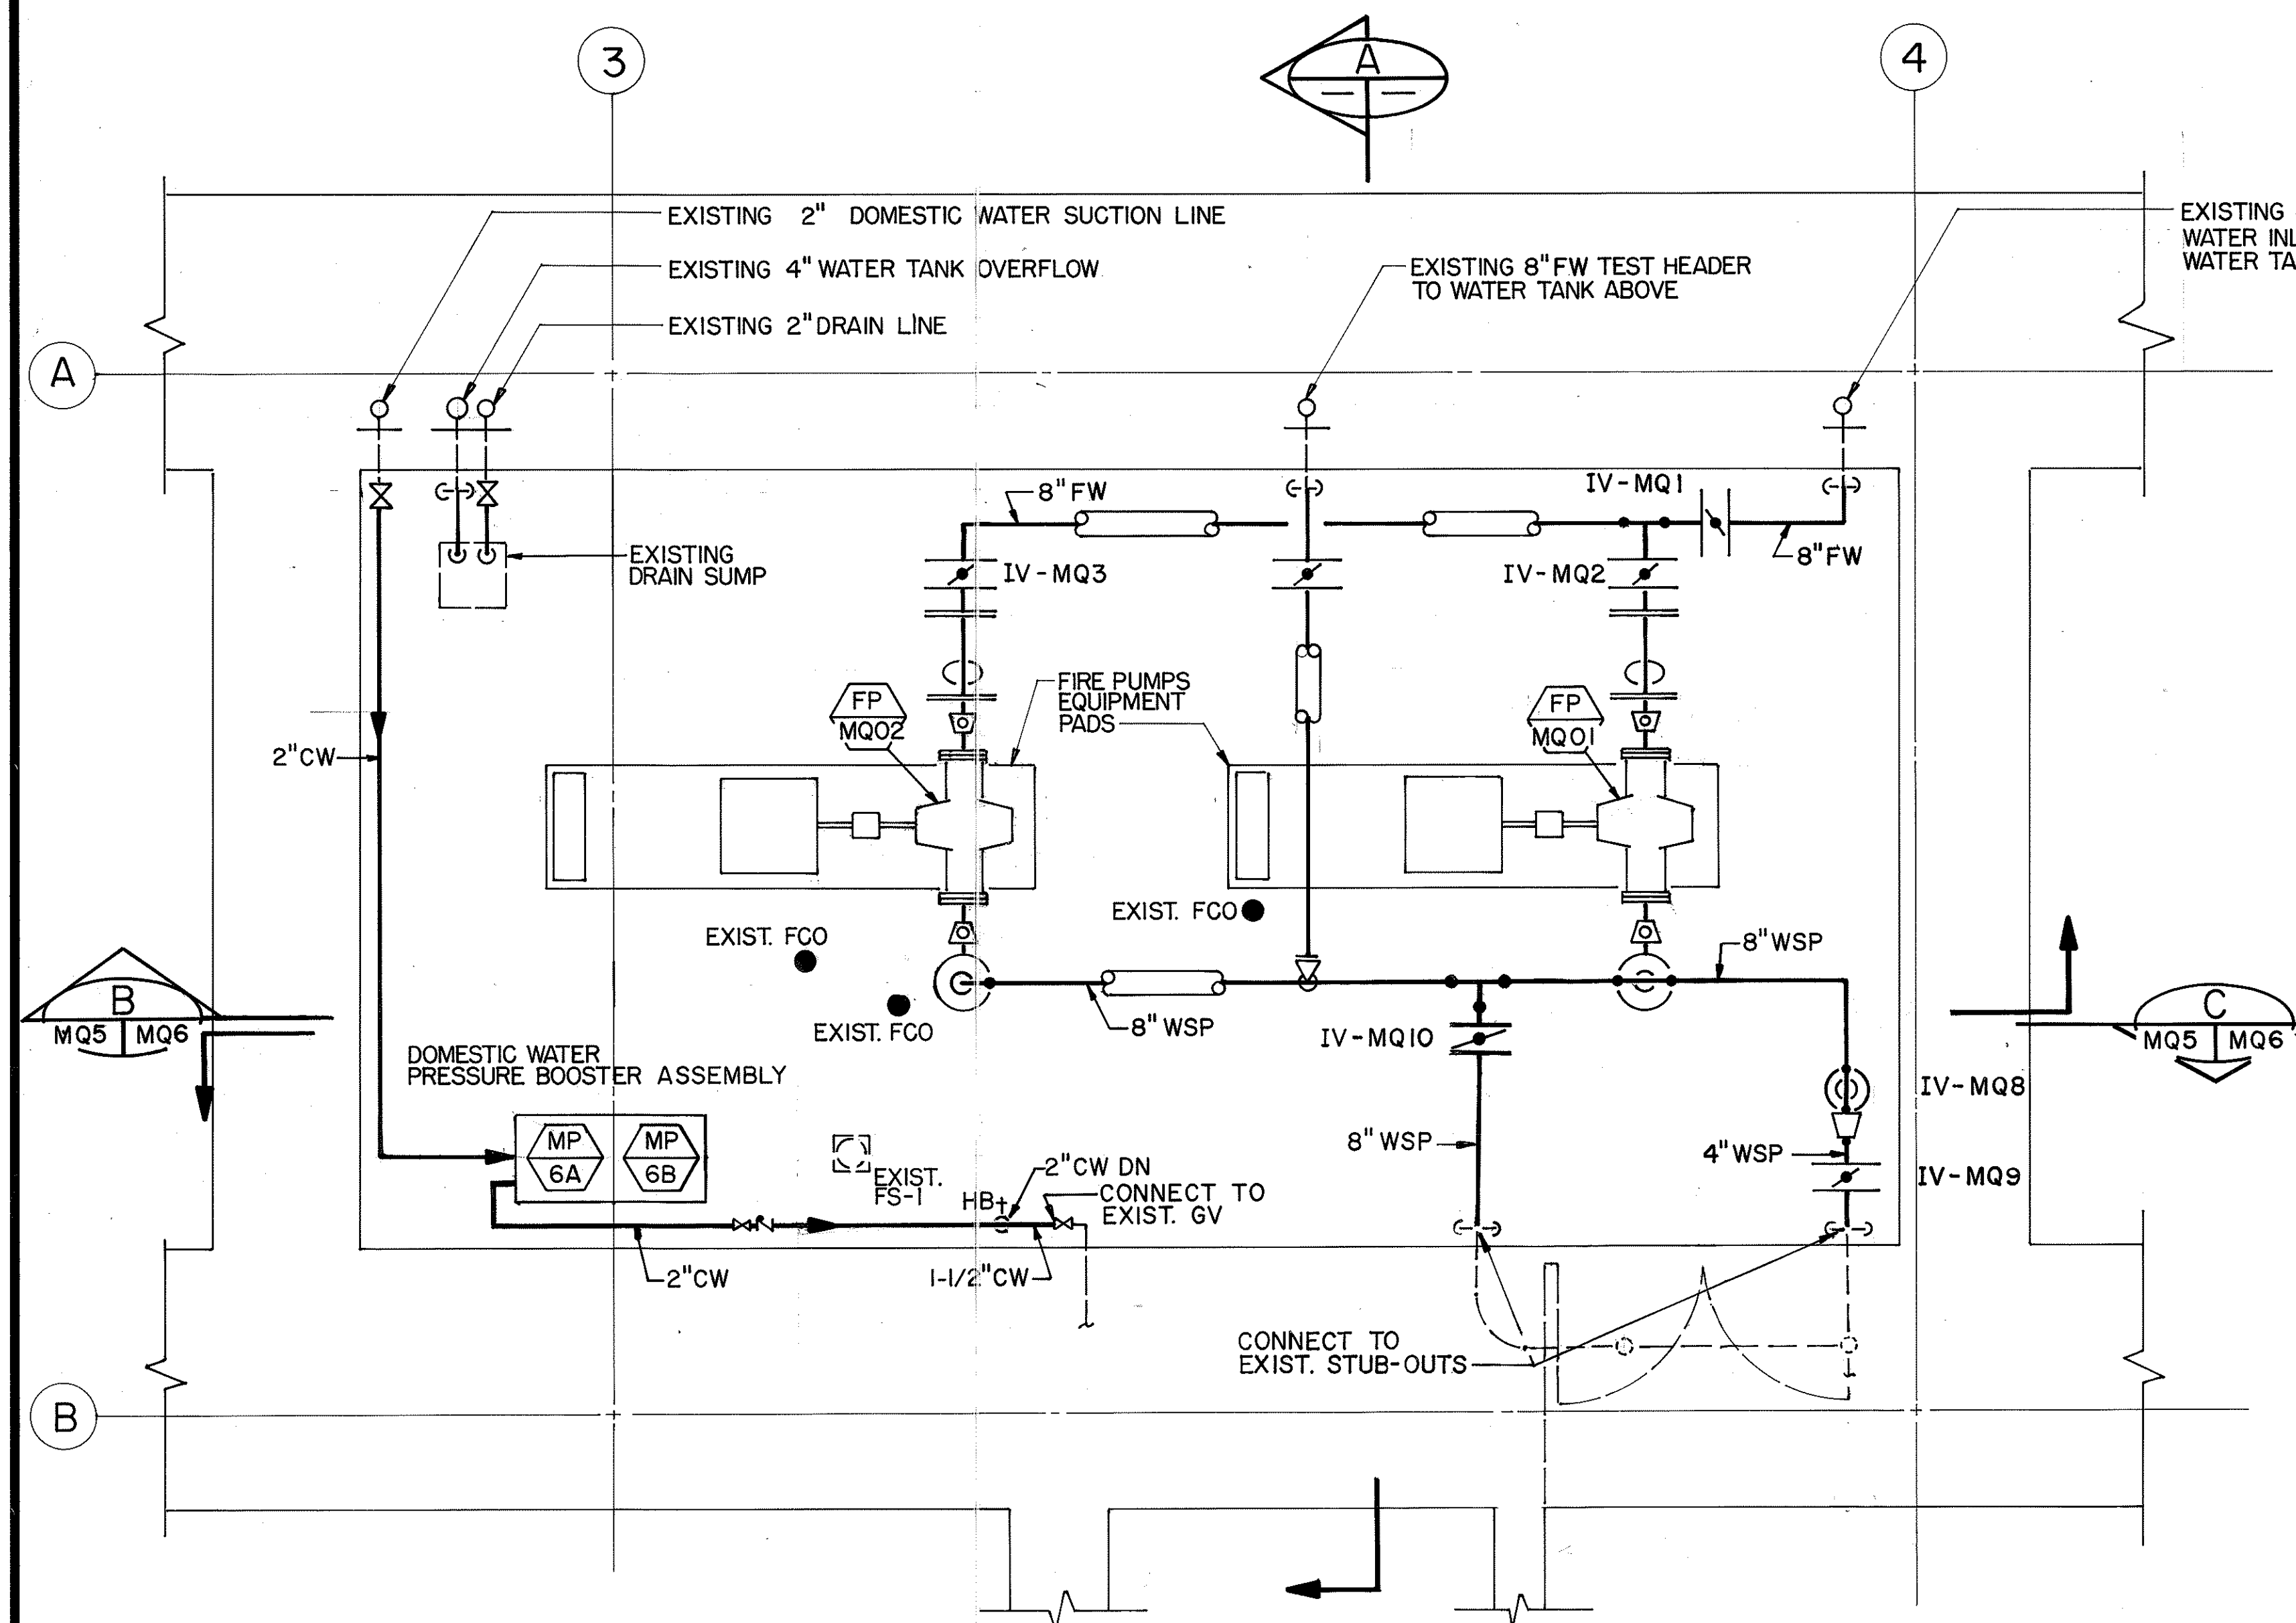


PUMP ROOM PARTIAL PLAN

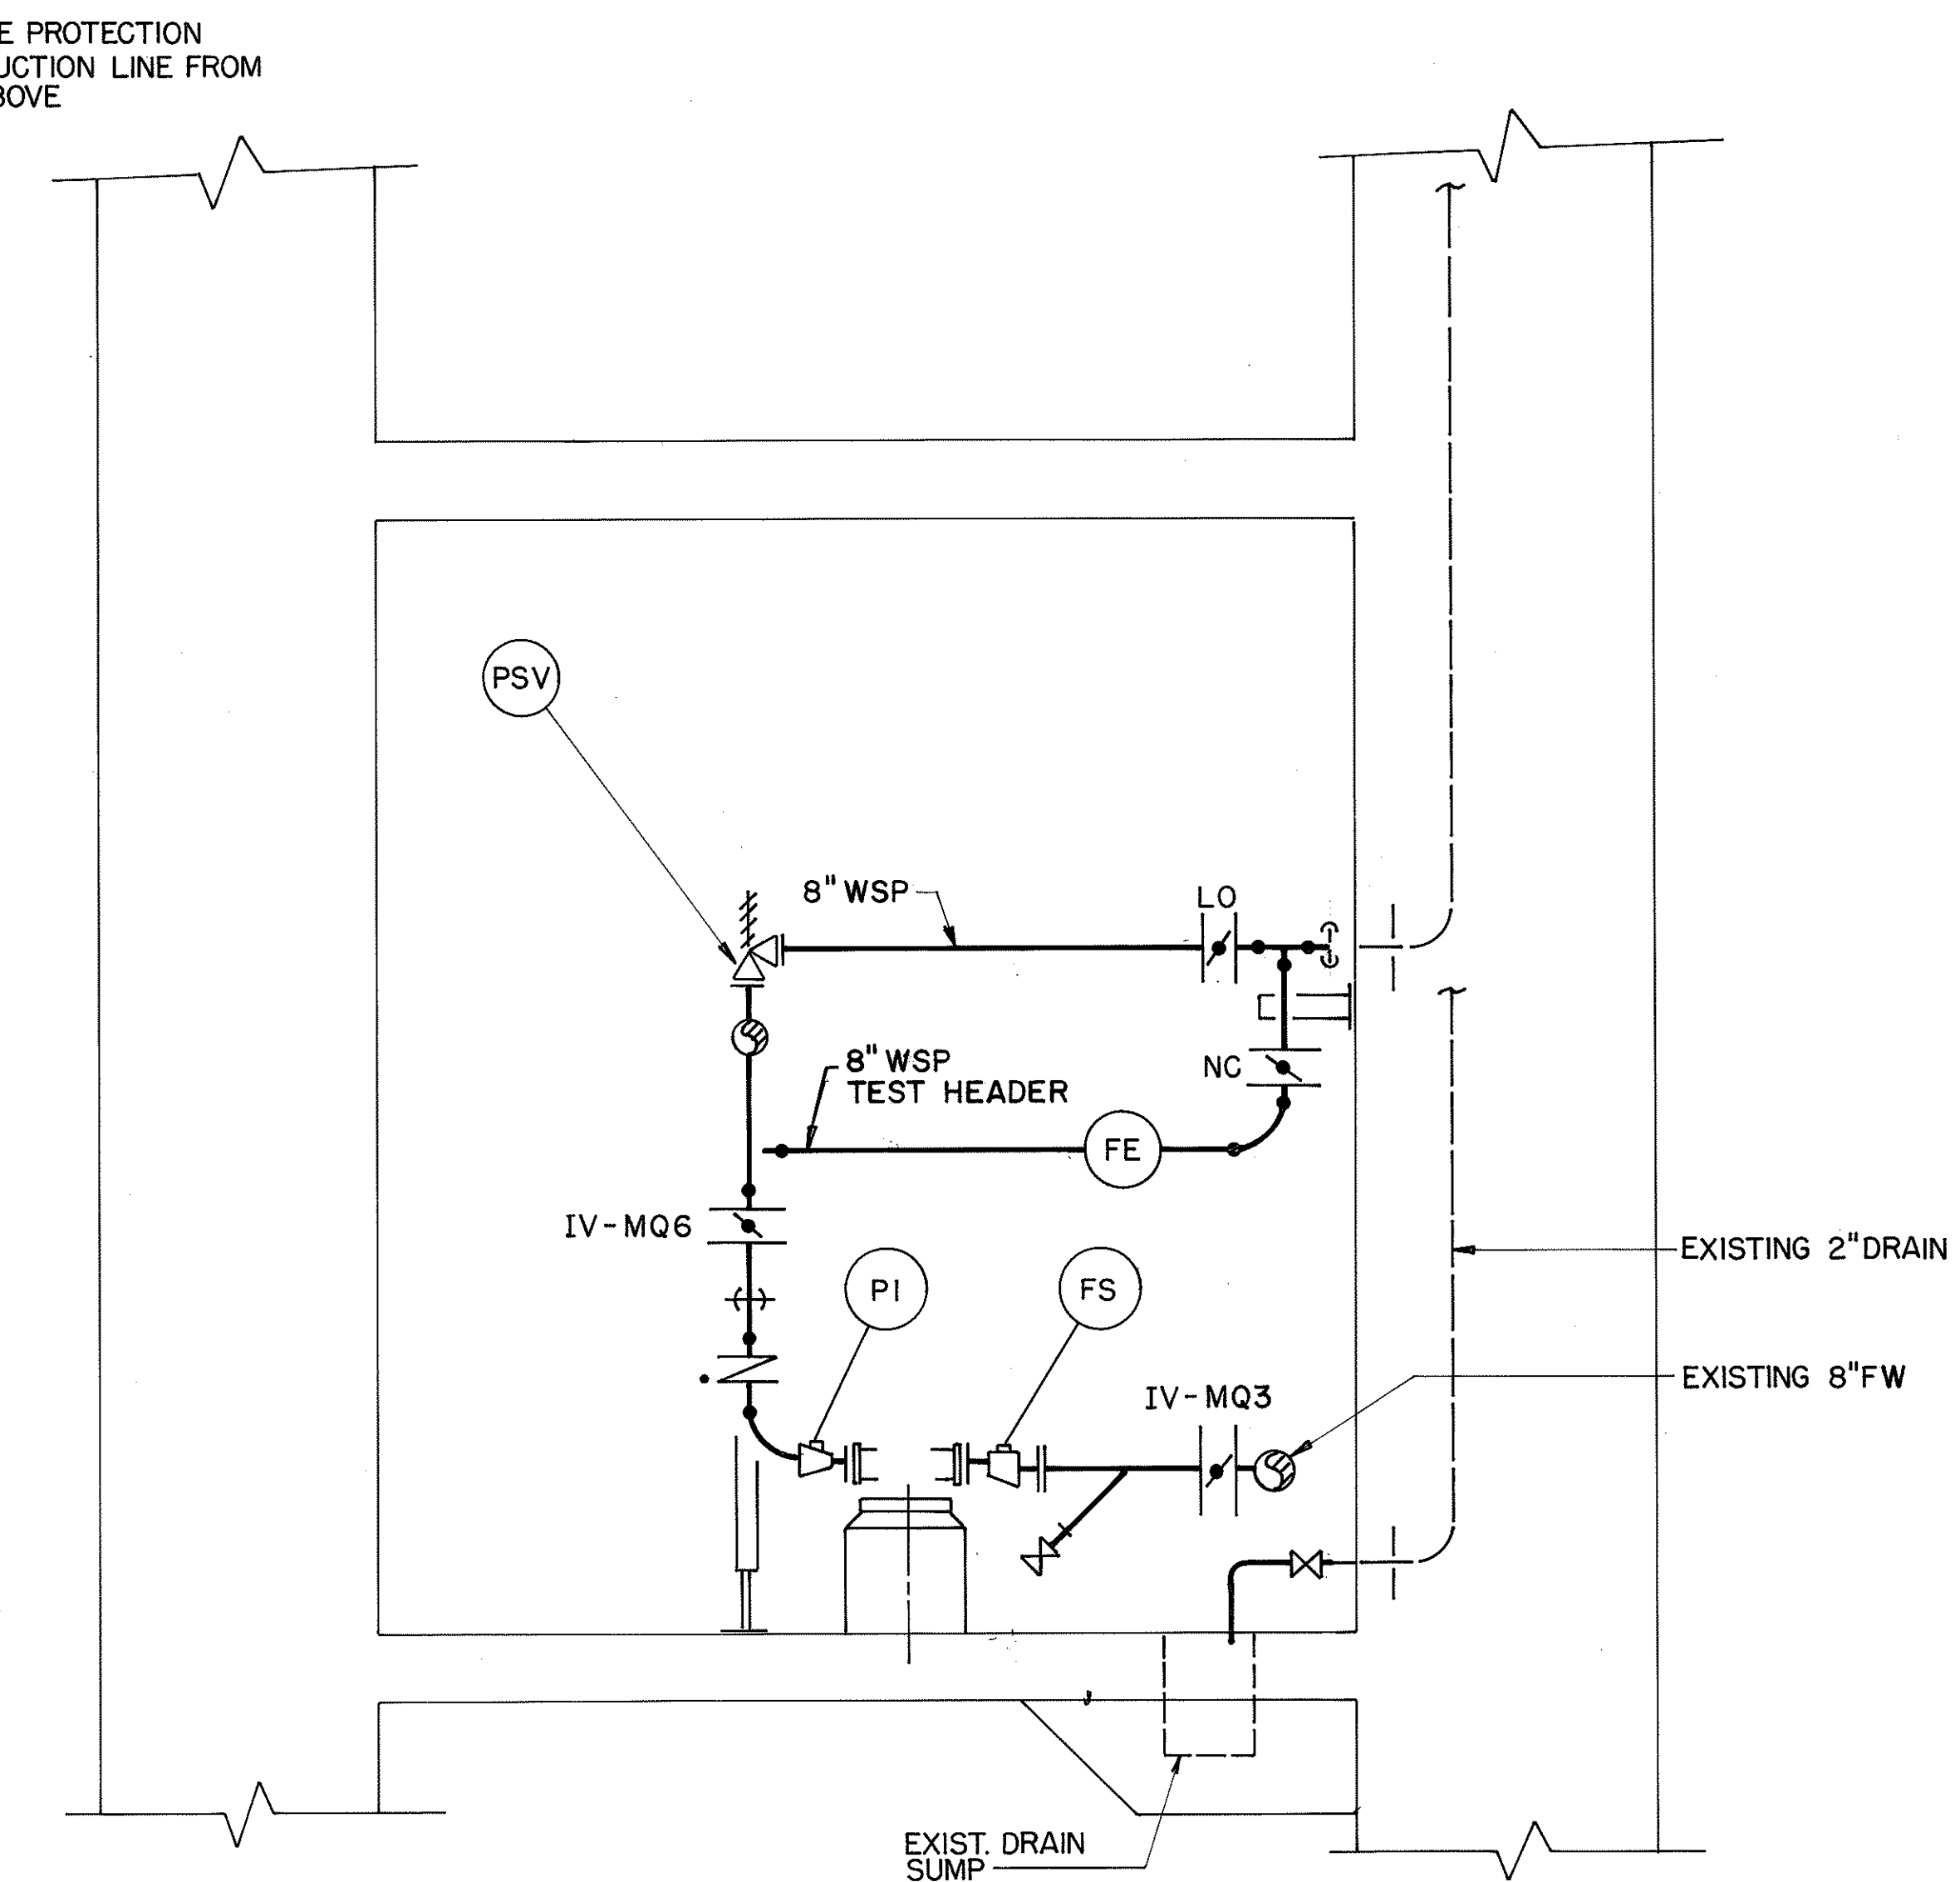

SECTION 

ORIGINAL PLAN	SURVEY PLOTTED BY <u>B. BUNYI</u>	DATE <u>2/10/89</u>
NOTE BOOK	DRAWN BY _____	_____
	TRACED BY _____	_____
	DESIGNED BY <u>P. L. LALOUE</u>	<u>1/09/89</u>
	QUANTITIES BY _____	_____
No. _____	CHECKED BY <u>J. N. QUE</u>	<u>06/04/90</u>

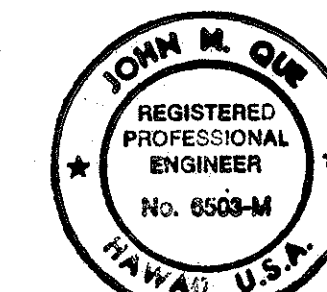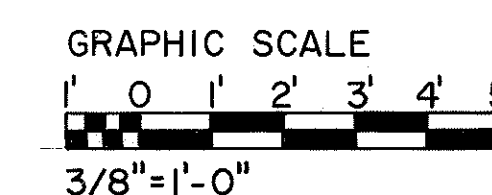

THIS WORK WAS PREPARED BY ME
OR UNDER MY SUPERVISION

John Doe

STATE OF HAWAII
DEPARTMENT OF TRANSPORTATION
HIGHWAYS DIVISION

PLUMBING - PUMP ROOM

PARTIAL PLAN & SECTION

HAIKU PORTAL BUILDING-OB


INTERSTATE ROUTE H-3

F.A.I. PROJ. NO. I-H3-I(66)

SCALE: 3/8"=1'-0"
DATE: APR 1992


SHEET NO. **MQ5** **OF 9 SHEETS**

FED. ROAD DIST. NO.	STATE	FED. AID PROJ. NO.	FISCAL YEAR	SHEET NO.	TOTAL SHEETS
HAWAII	HAW.	I-H3-1(66)	1992	91	440

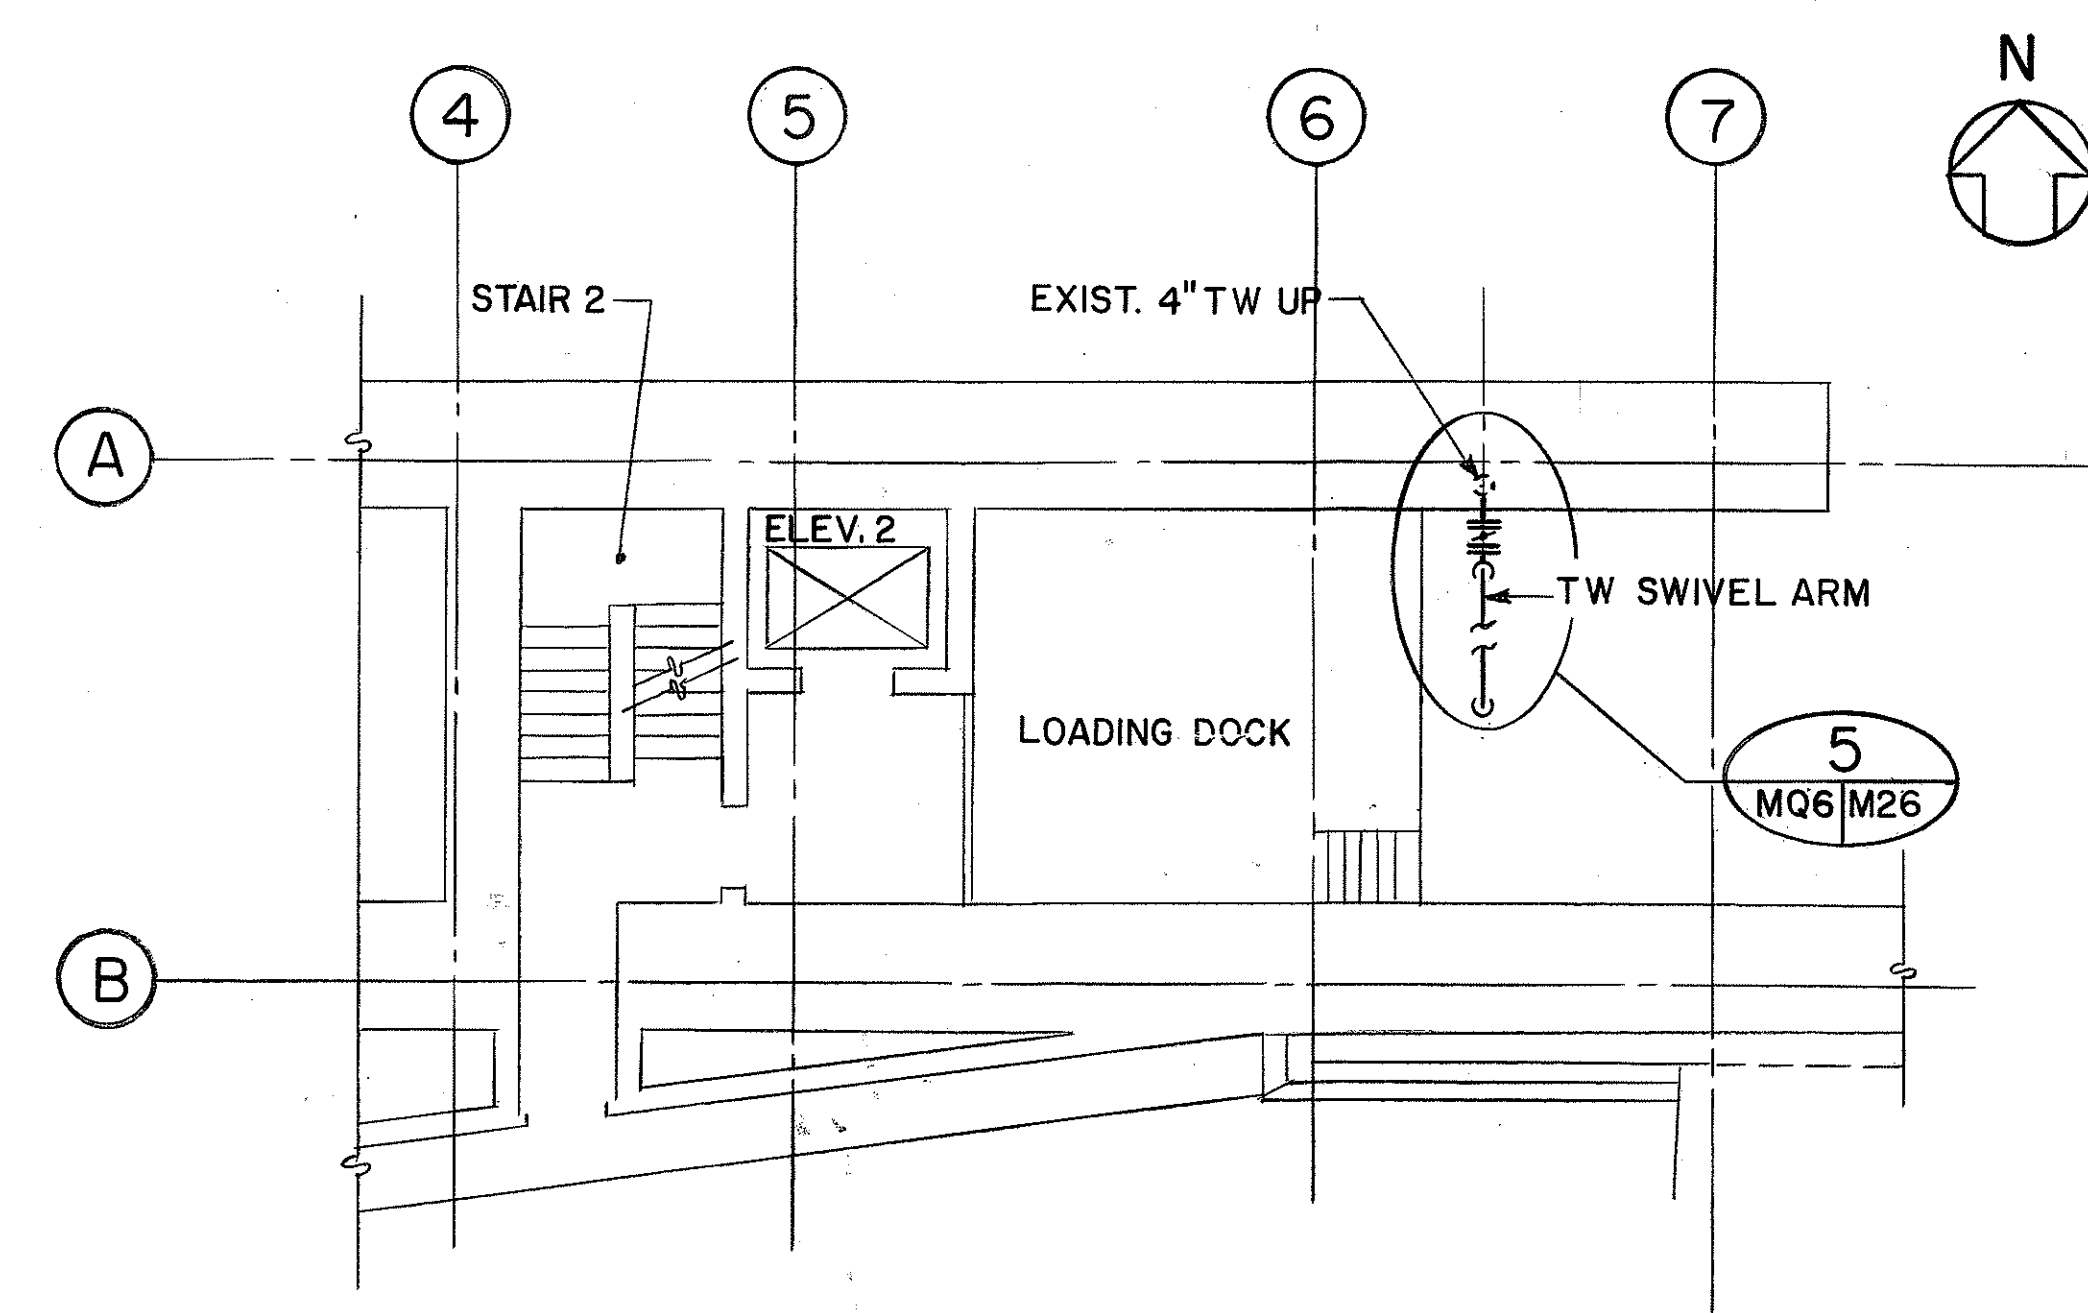

LEVEL A PARTIAL PLAN
SCALE: 1/8"=1'-0"

SECTION
SCALE: 3/8"=1'-0"

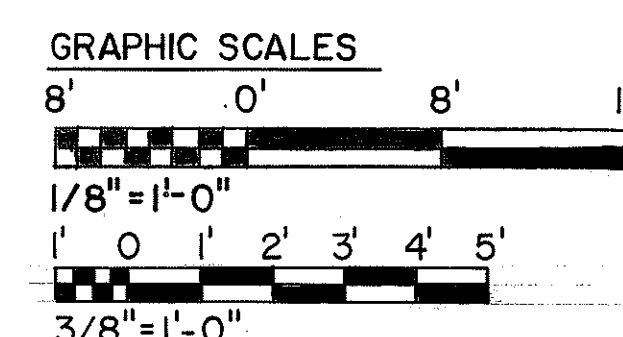

THIS WORK WAS PREPARED BY ME
OR UNDER MY SUPERVISION

DATE	REVISION

STATE OF HAWAII
DEPARTMENT OF TRANSPORTATION
HIGHWAYS DIVISION

PUMP ROOM SECTIONS

& PARTIAL PLAN


HAIKU PORTAL BUILDING—OB

INTERSTATE ROUTE H-3
F.A.I. PROJ. NO. I-H3-1(66)


SCALE: AS NOTED
DATE: APR 1992

SHEET NO. M46
OF 9 SHEETS

FED. ROAD DIST. NO.	STATE	FED. AID PROJ. NO.	FISCAL YEAR	SHEET NO.	TOTAL SHEETS
HAWAII	HAW.	I-H3-1(66)	1992	92	440

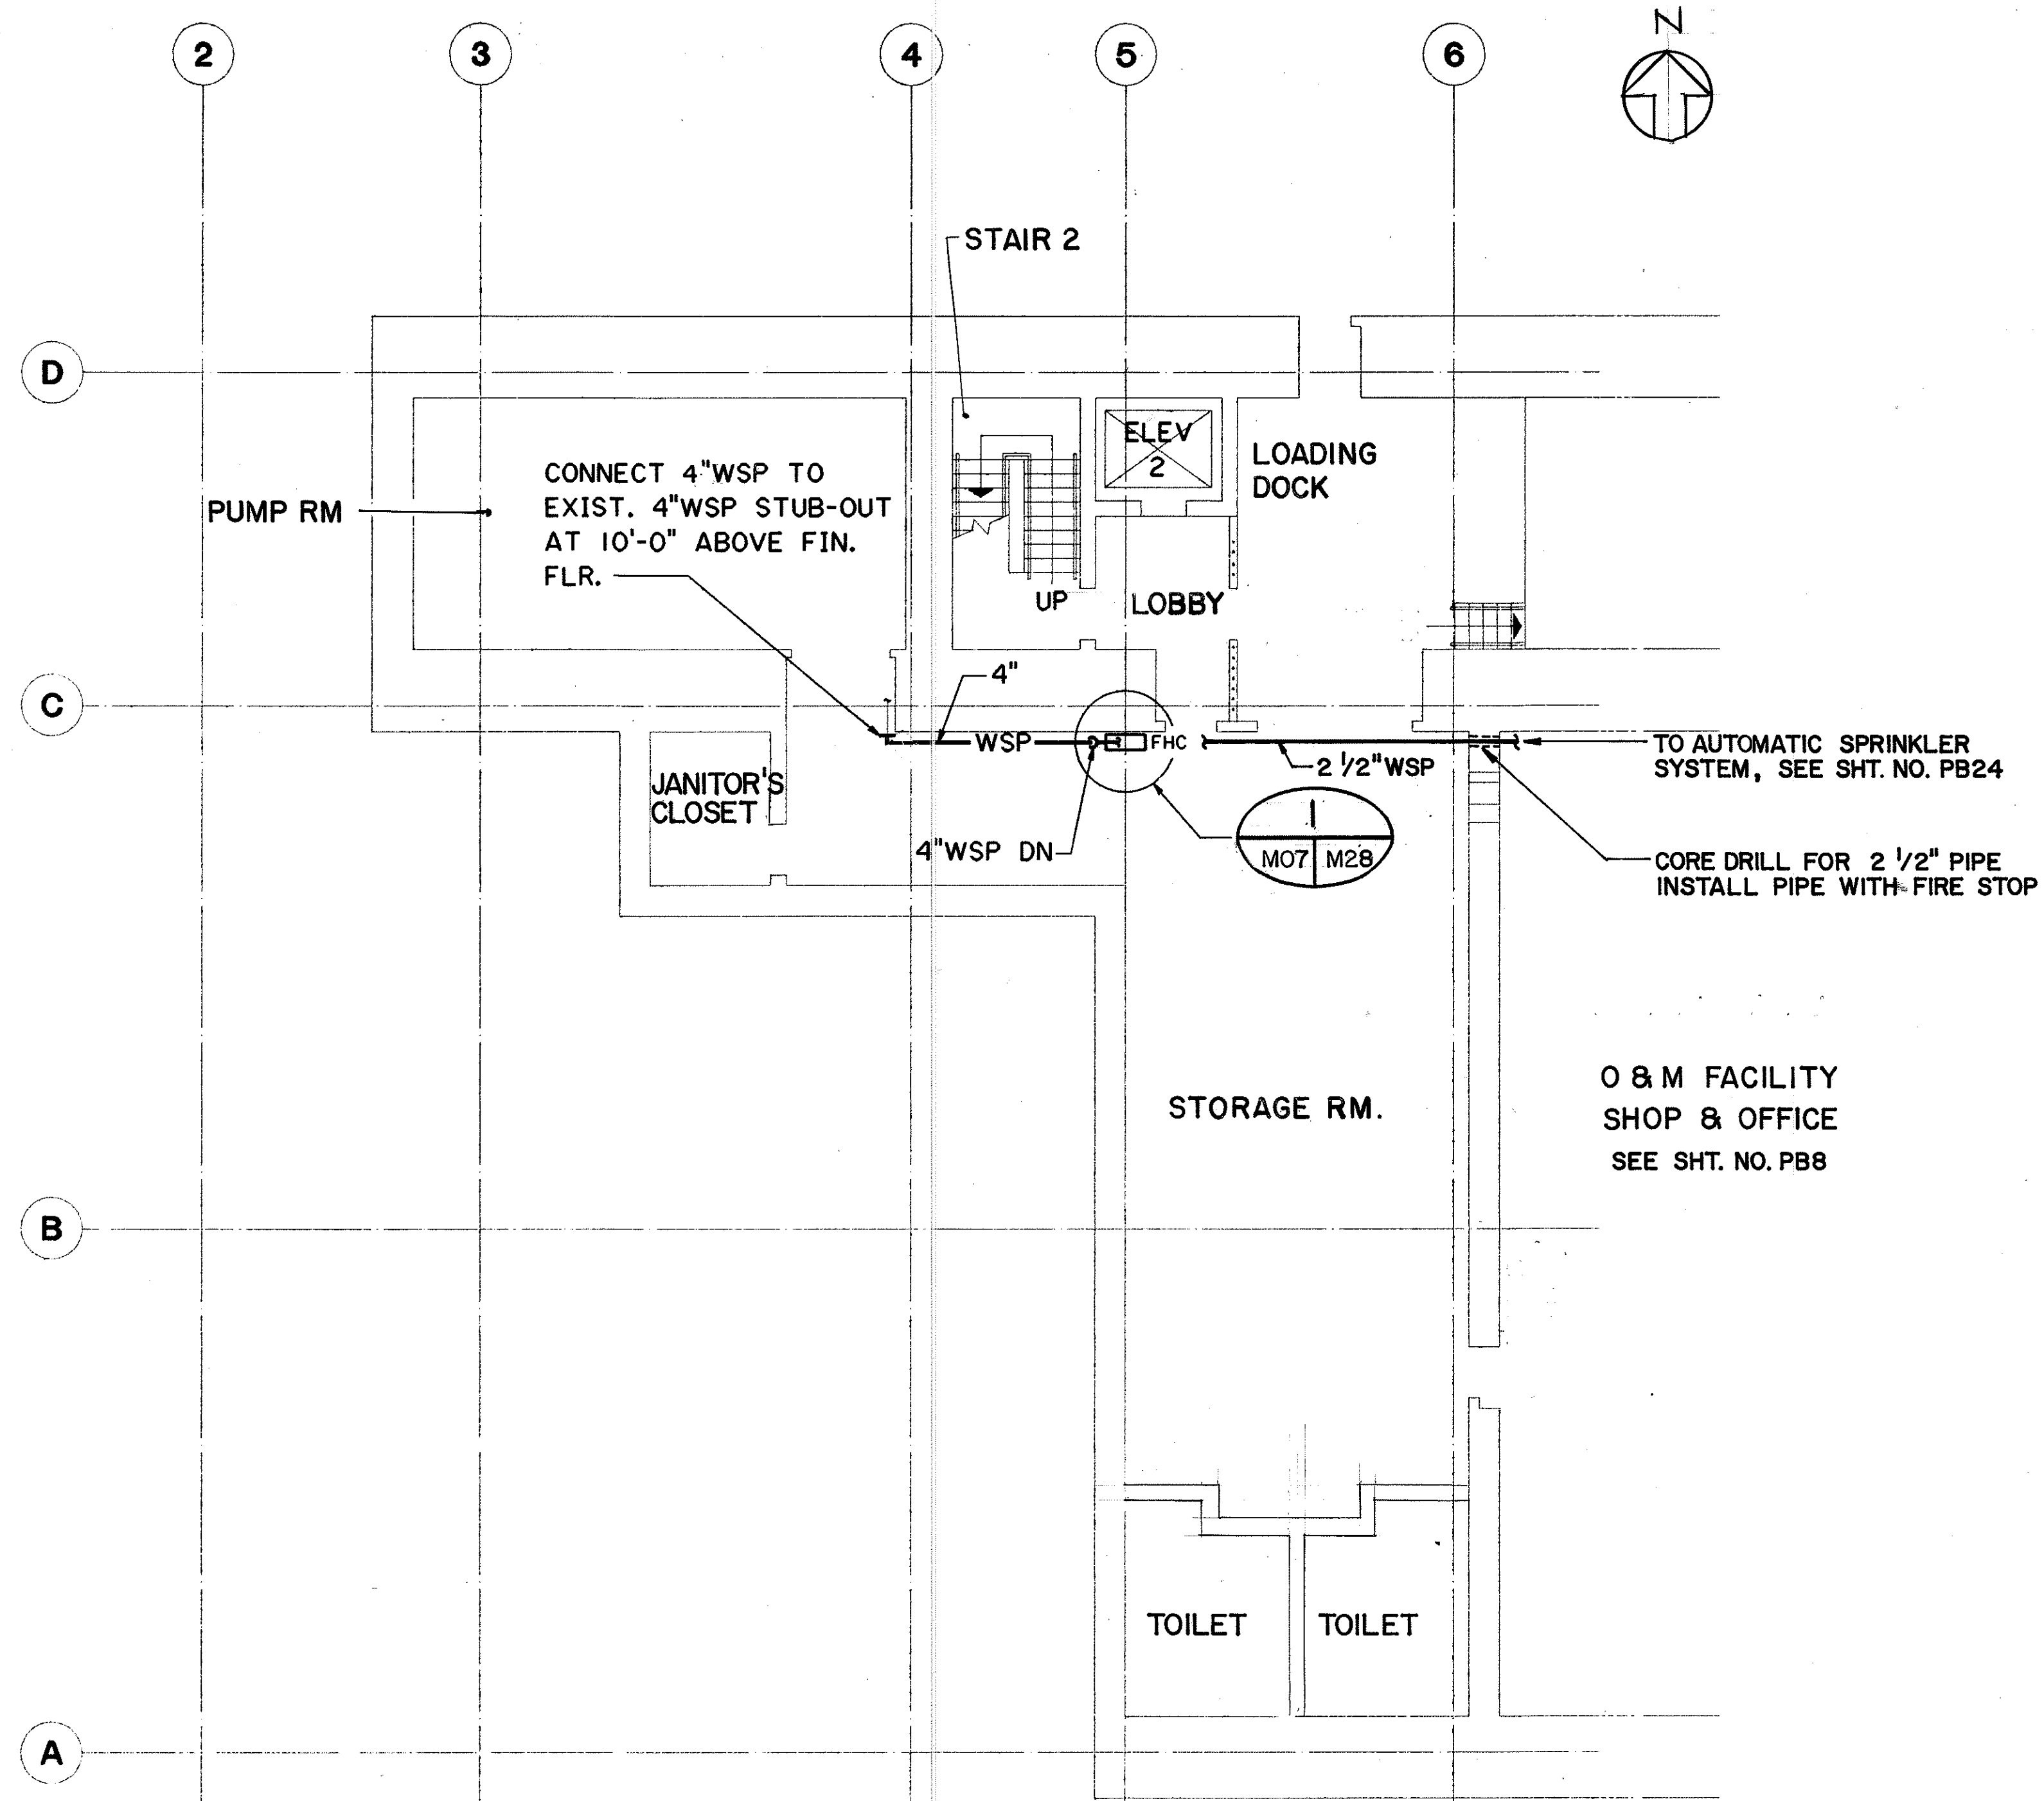

LEVEL A PARTIAL PLAN

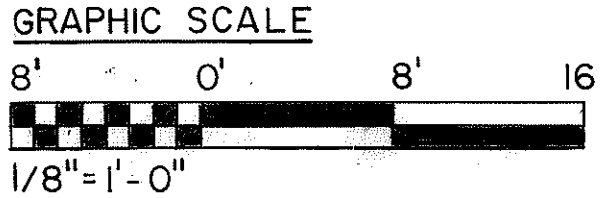

JOHN N. QUE
REGISTERED
PROFESSIONAL
ENGINEER
No. 6503-M
HAWAII, U.S.A.

THIS WORK WAS PREPARED BY ME
OR UNDER MY SUPERVISION

John N. Que

FOR DETAIL AS-BUILT INFORMATION
REFER TO CONSTRUCTION SUBMITTALS

DATE	REVISION
7/22/92	APPENDUM I - ADDED WSP TO O & M SHOP/OFFICE
DATE	REVISION
STATE OF HAWAII DEPARTMENT OF TRANSPORTATION HIGHWAYS DIVISION	
FIRE PROTECTION - LEVEL A PARTIAL PLAN	
HAIKU PORTAL BUILDING-0B INTERSTATE ROUTE H-3 F.A.I. PROJ. NO. I-H3-1(66)	
SCALE: 1/8"=1'-0"	DATED: APR 1992
SHEET NO. MQ7	OF 9 SHEETS



SURVEY PLOTTED BY	DATE
DRAWN BY	02/10/90
CHECKED BY	02/06/90
NOTED BY	06/08/90
NO.	

A circular professional engineer seal for John N. Que. The outer ring contains the text "JOHN N. QUE" at the top and "HAWAII, U.S.A." at the bottom. The inner circle contains the text "REGISTERED PROFESSIONAL ENGINEER" and "No. 6503-M". A small star is located on the left side of the inner circle.


John Doe

93



FED. ROAD DIST. NO.	STATE	FED. AID PROJ. NO.	FISCAL YEAR	SHEET NO.	TOTAL SHEETS
HAWAII	HAW.	I-H3-1(66)	1992	94	440

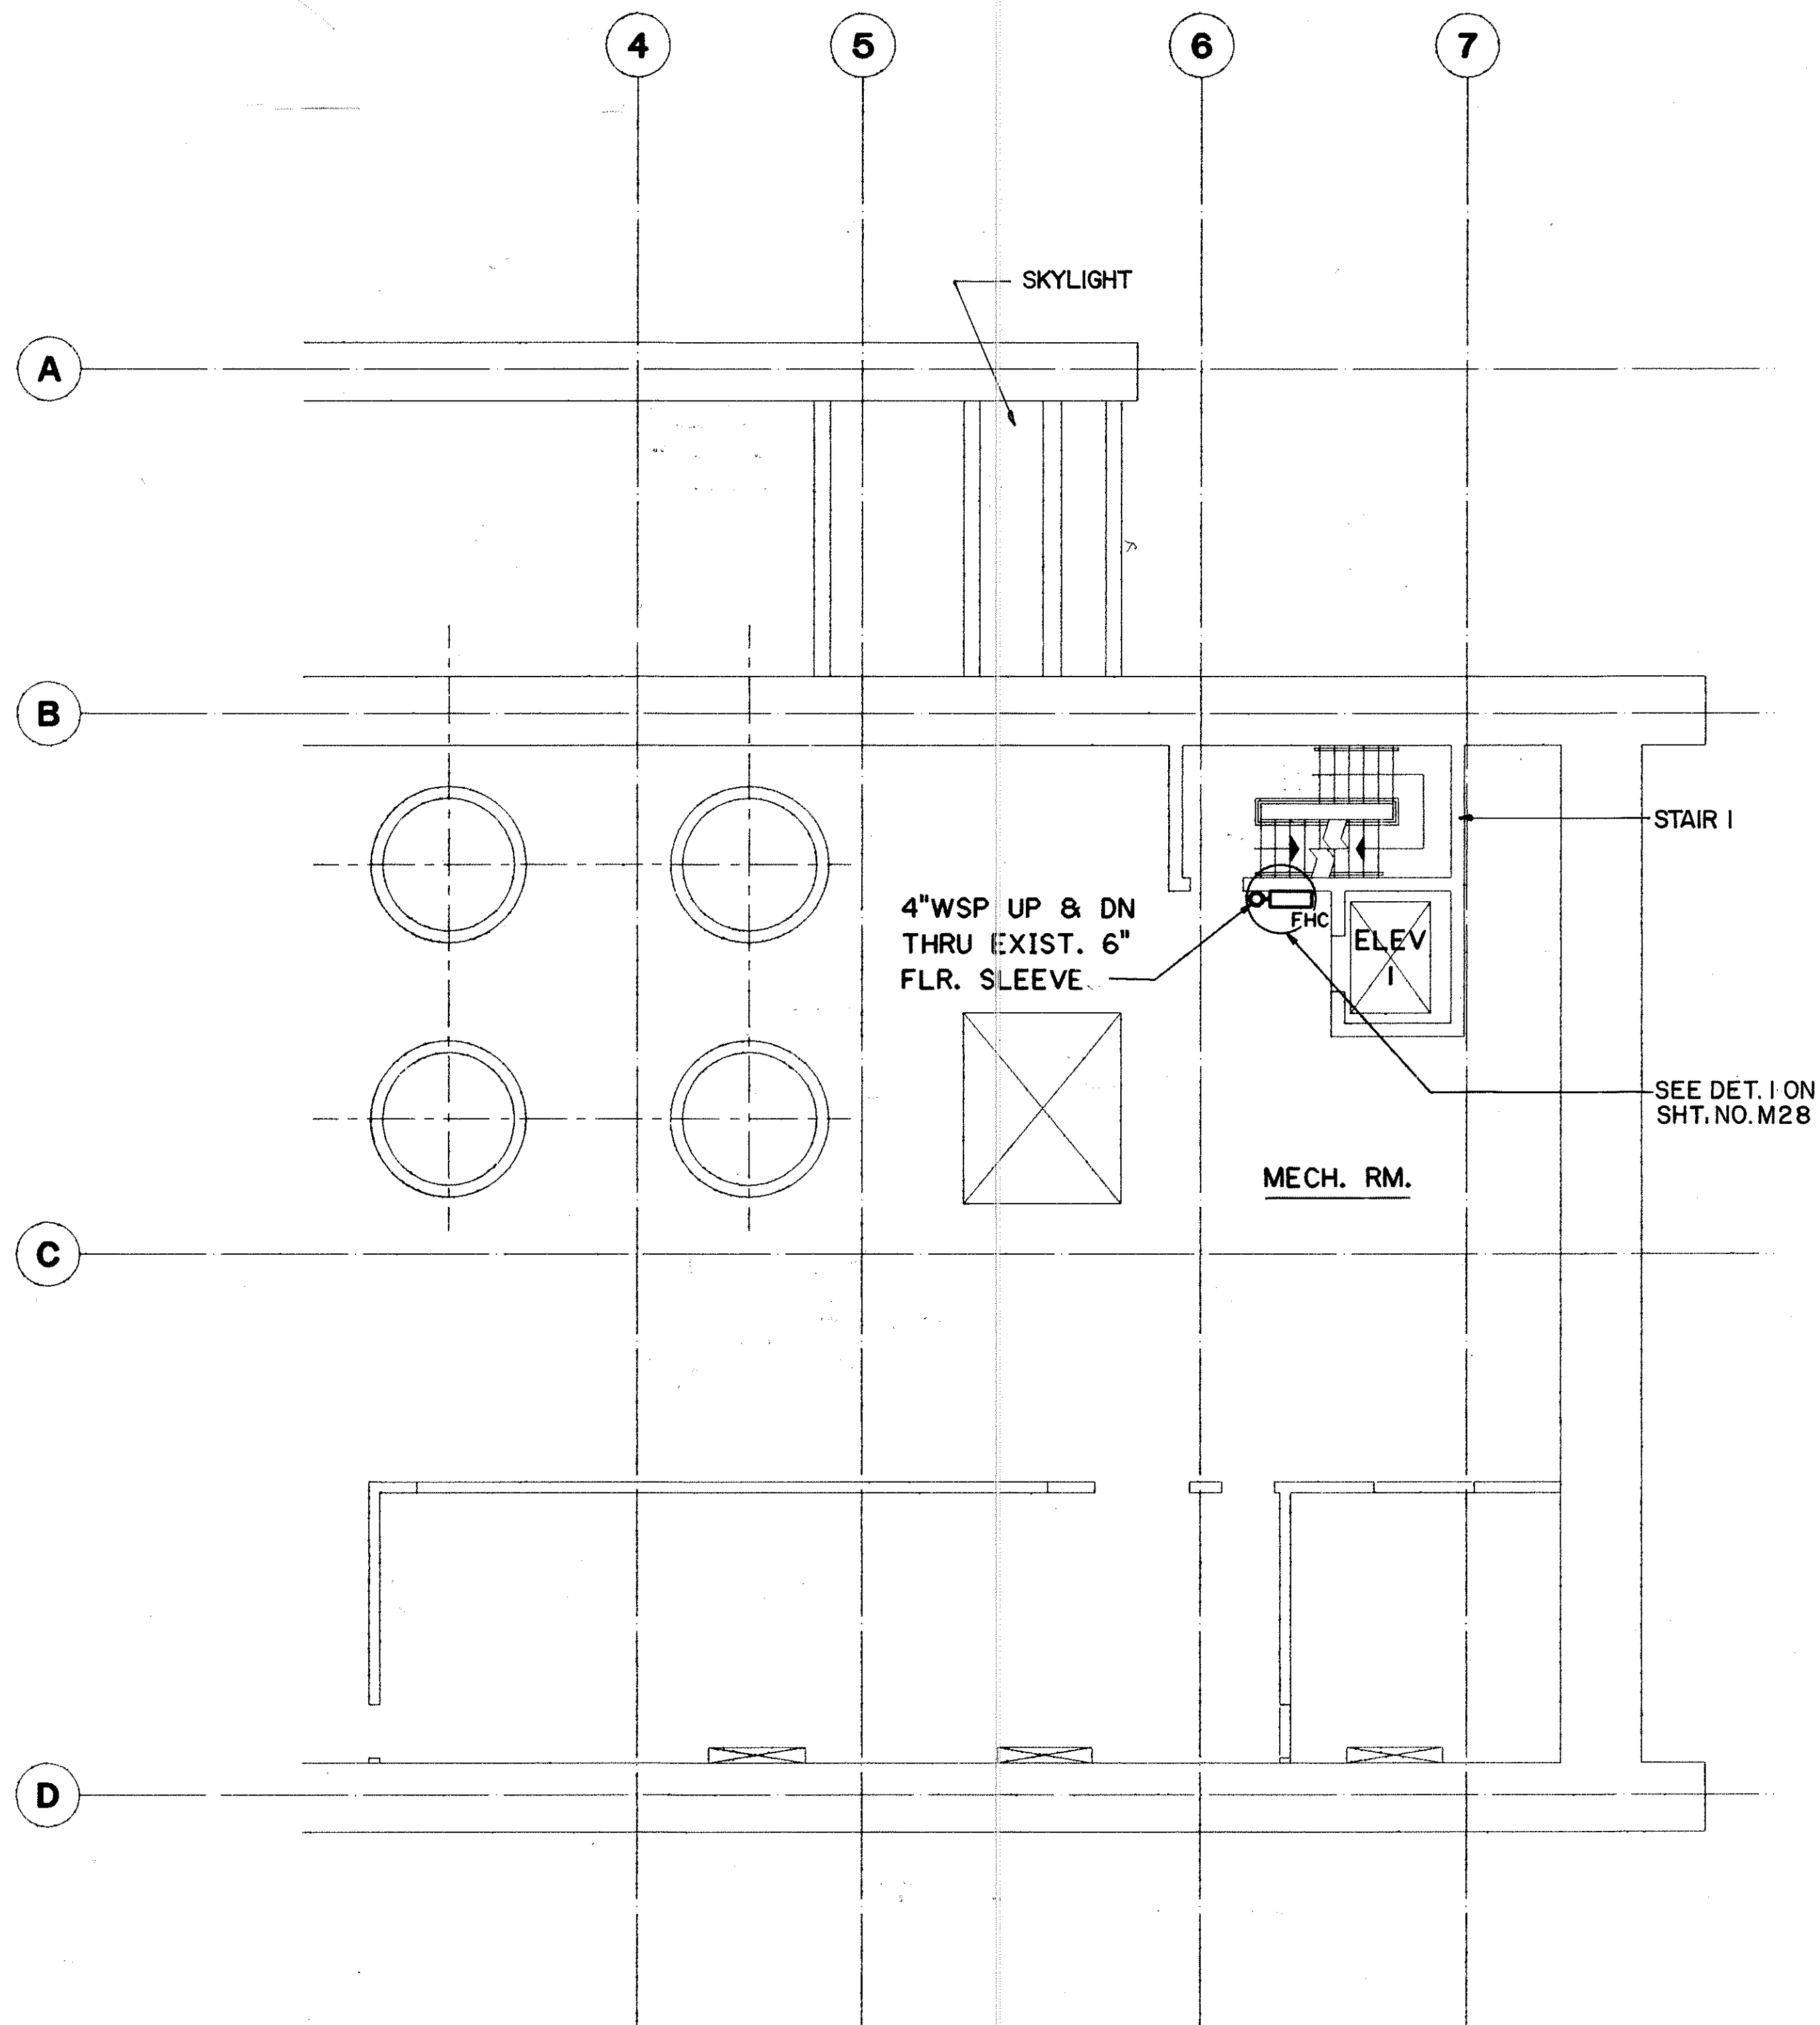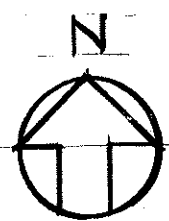

LEVEL 4 PARTIAL PLAN

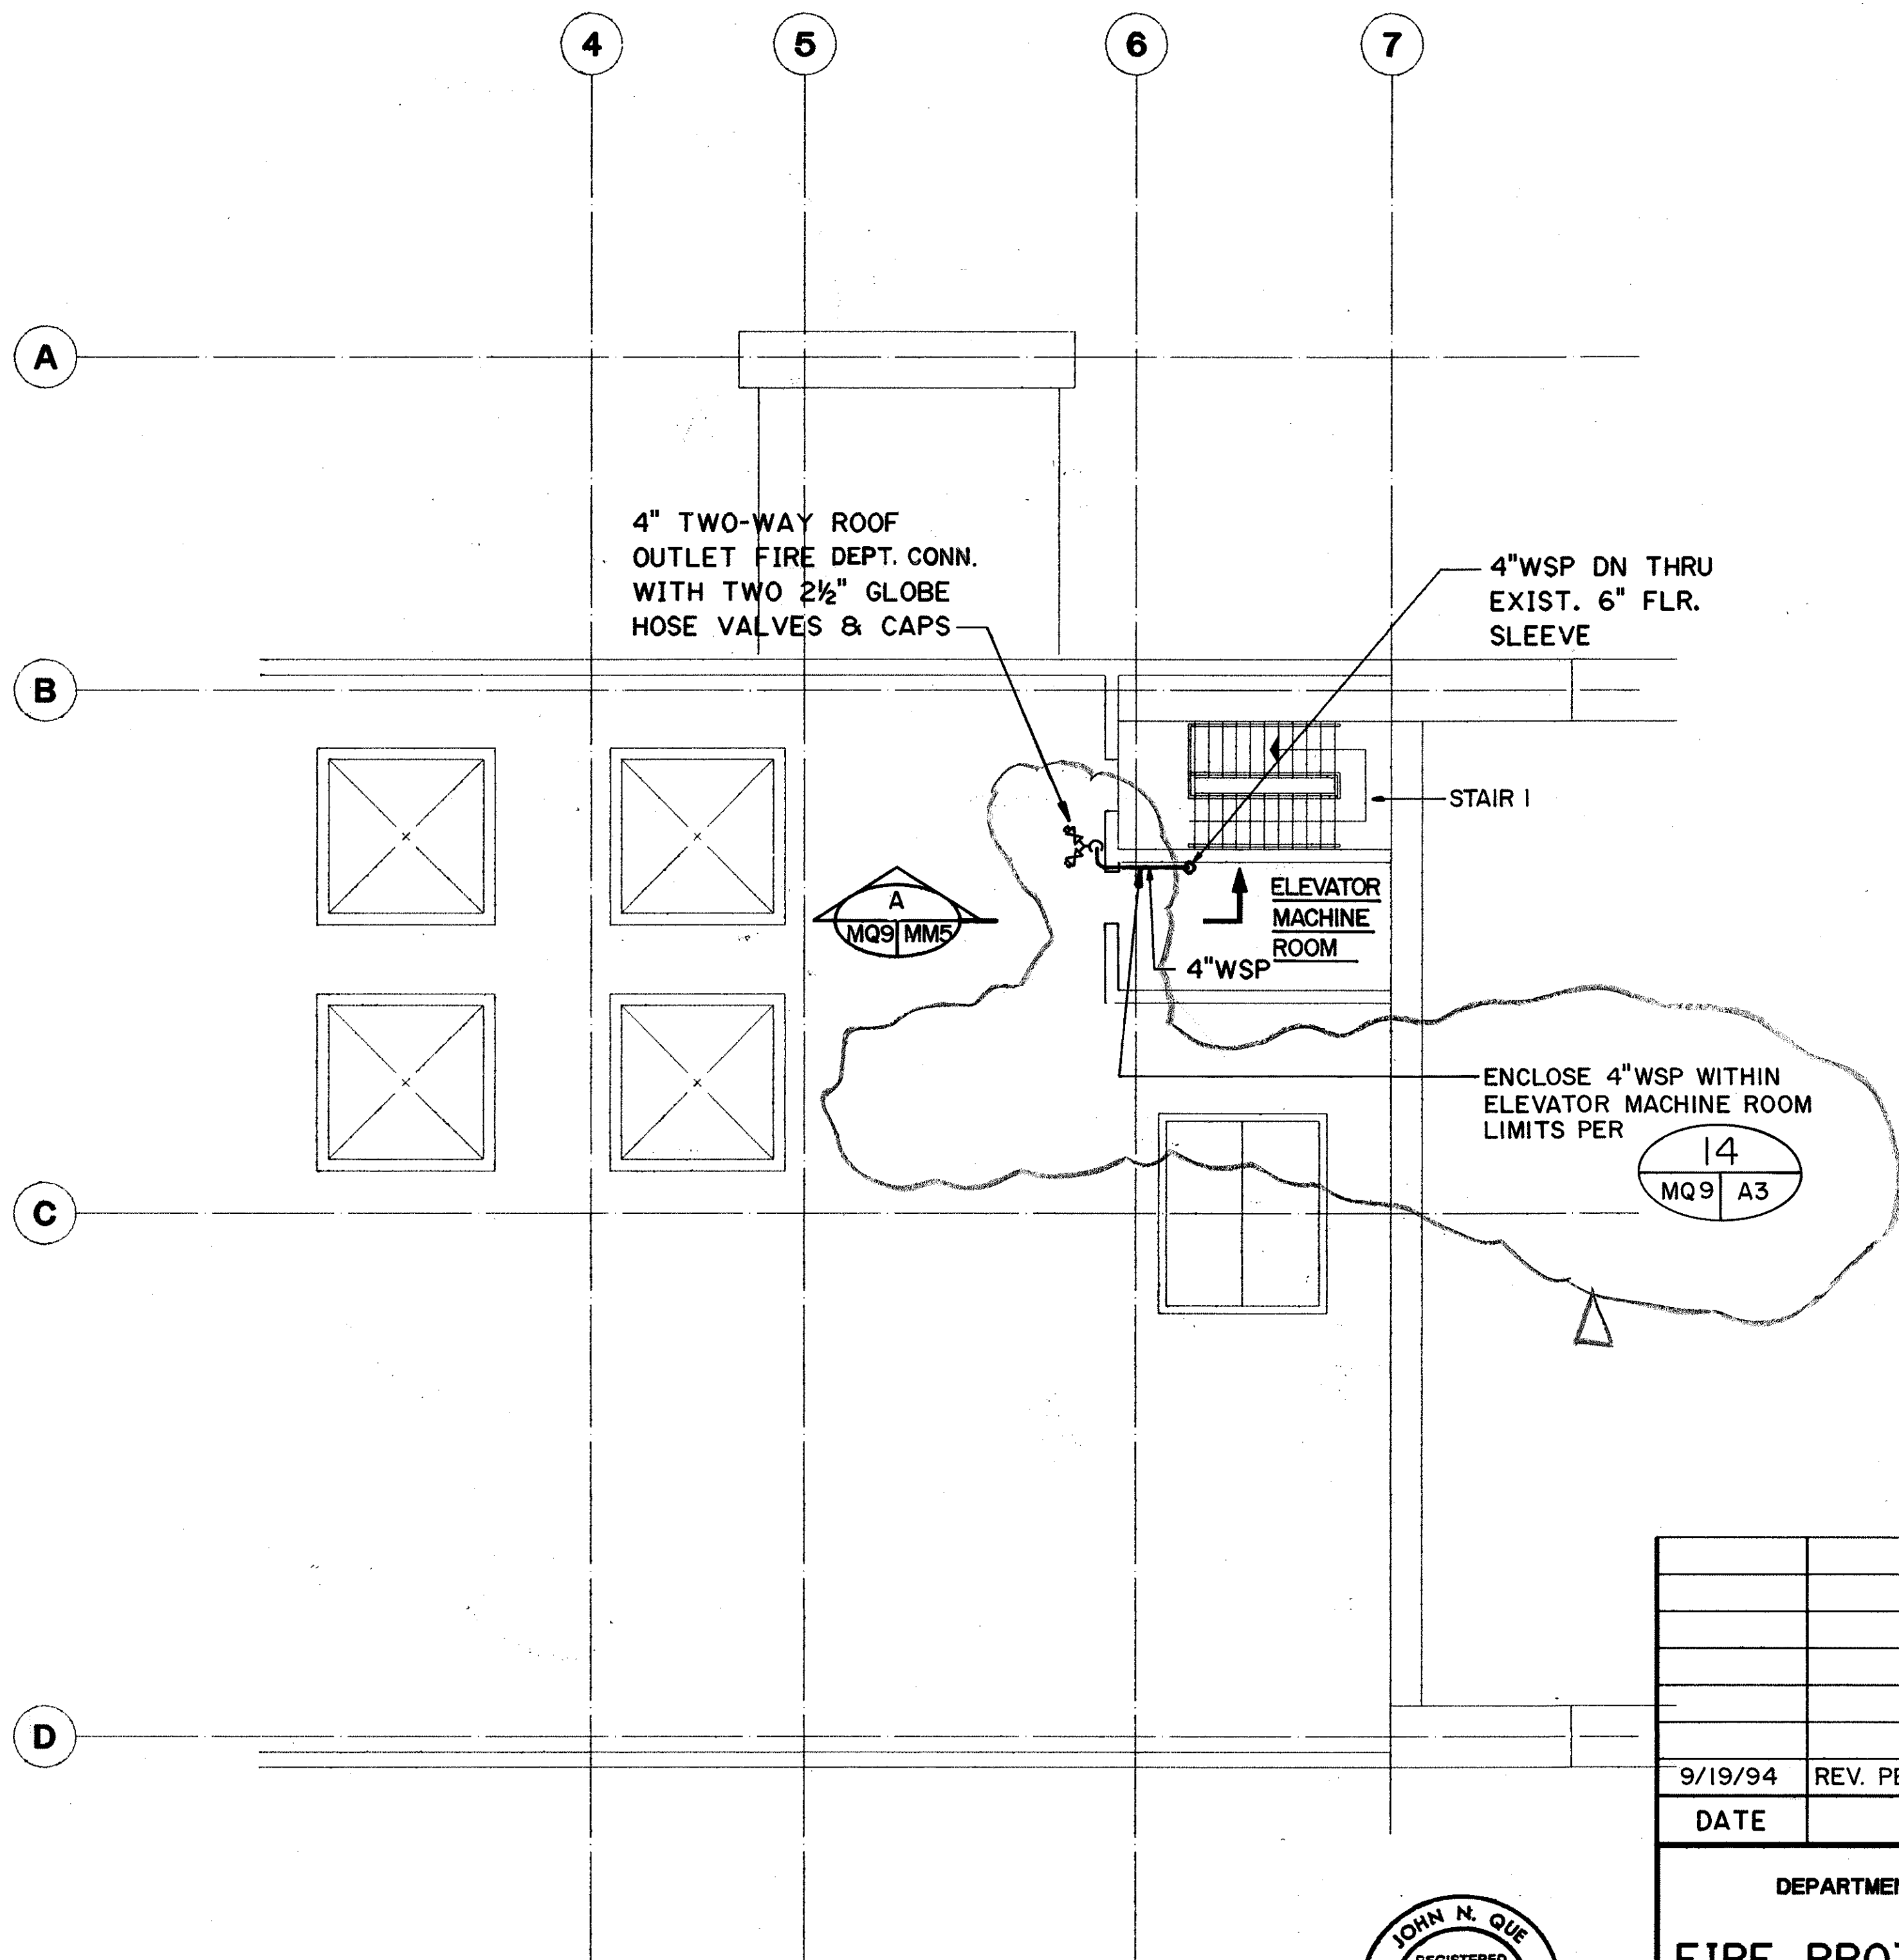

ROOF LEVEL PARTIAL PLAN

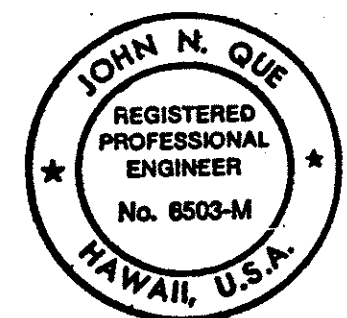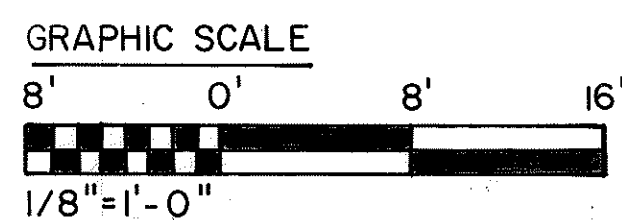

THIS WORK WAS PREPARED BY ME
OR UNDER MY SUPERVISION

John N. Que

9/19/94	REV. PER DCN-66-052
DATE	REVISION
STATE OF HAWAII DEPARTMENT OF TRANSPORTATION HIGHWAYS DIVISION	
FIRE PROTECTION -LEVEL 4 & ROOF PARTIAL PLANS	
HAIKU PORTAL BUILDING - 0B	
INTERSTATE ROUTE H-3	
F.A.I. PROJ. NO. I-H3-1(66)	
SCALE: 1/8"=1'-0"	DATE: APR. 1992
SHEET NO. MQ9	OF 9 SHEETS

ORIGINAL PLAN	DATE 05/12/90
DRAWN BY B. BUNY	CHECKED BY J.N. QUE
NOTED BY P.L. LAJOLLE	DATE 02/27/90
QUANTITIES BY J.N. QUE	DATE 05/08/90