

ORIGINAL PLAN	DATE	1/90
NOTE BOOK	DESIGNED BY	HP/CH
No.	QUANTITIES BY	CH/CH
	CHECKED BY	CH/CH

GENERAL NOTES FOR SIGN STRUCTURES AND FARADAY SHIELD SUPPORTS

FED. ROAD DIST. NO.	STATE	FED. AID PROJ. NO.	FISCAL YEAR	SHEET NO.	TOTAL SHEETS
HAWAII	HAW.	I-H3-1(66)	1992	363	440

1. DESIGN SPECIFICATIONS:

AASHTO STANDARD SPECIFICATIONS FOR STRUCTURAL SUPPORTS FOR HIGHWAY SIGNS, LUMINAIRES AND TRAFFIC SIGNALS, CURRENT EDITION

2. DESIGN DATA:

WIND LOADING: DESIGN WIND SPEED = 80 MPH. FOR WIND LOAD NORMAL TO FACE OF SIGN AND TRANSVERSE TO FACE OF SIGN, SEE DESIGN SPECIFICATIONS.
WALKWAYS: SEE NOTES ON SHEET NO. SS28.
ICE LOAD: NONE
STRUCTURAL STEEL: ASTM A36
HIGH STRENGTH BOLTS: ASTM A325 (FRICTION - TYPE CONNECTION)
STRUCTURAL TUBING: ASTM A500 GRADE B
STEEL PIPE: ASTM A53 TYPE E GRADE B

3. WELDING:

ALL WELDING TO BE CONTINUOUS WELDS AND AS NOTED ON THE PLANS.
ALL WELDING SHALL CONFORM TO THE REQUIREMENTS OF ANSI/AASHTO/AWS D1.5-88 "BRIDGE WELDING CODE".

4. MATERIALS:

- A. SIGN SUPPORT BOX TRUSS MEMBERS AND SUPPORTING POSTS; SHEET METAL SIDING AND EDGINGS; CONNECTION BOLTS; NUT AND WASHERS; TO BE STRUCTURAL STEEL. TUBULAR SECTION SUPPORTING FARADAY SHIELD SHALL BE STRUCTURAL TUBING. ALL SURFACES SHALL BE HOT-DIPPED GALVANIZED AFTER FABRICATION PRIOR TO PAINTING. SEE SPECIFICATIONS AND "RIBBED SHEET METAL NOTES" ON SHEET NO. SS29.
- B. GALVANIZED SURFACES OF SUPPORT STRUCTURES FOR OVERHEAD SIGNS, LANE CONTROL DISPLAY SIGNALS AND FARADAY SHIELDS (NOTE A. ABOVE) SHALL BE PAINTED TO WARM GRAY COLOR. SEE SPECIFICATIONS.
- C. CONTACT SURFACES IN HIGH STRENGTH (H.S.) BOLT CONNECTIONS SHALL NOT BE PAINTED. THE GALVANIZING ON THESE SURFACES SHALL BE LIGHTLY SCORED BY WIRE BRUSHING PRIOR TO ASSEMBLY.
- D. HIGH STRENGTH BOLTS SHALL BE GALVANIZED, FURNISHED AND INSTALLED IN CONFORMANCE WITH CURRENT ASTM A325 WITH LUBRICATED NUTS.
- E. LEVELING GROUT SHALL BE NON-SHRINK AND NON-METALLIC.

5. CONSTRUCTION METHOD:

SEE HAWAII STANDARD SPECIFICATIONS FOR ROAD AND BRIDGE CONSTRUCTION, 1985 EDITION, AASHTO STANDARD SPECIFICATIONS FOR STRUCTURAL SUPPORTS FOR HIGHWAY SIGNS, LUMINAIRES AND TRAFFIC SIGNALS, CURRENT EDITION AND SPECIAL PROVISIONS.

6. GENERAL:


- A. PRIOR TO FABRICATION OF FRAMES OF SUPPORT STRUCTURES FOR OVERHEAD SIGNS, LANE CONTROL DISPLAY SIGNALS AND FARADAY SHIELDS, THE CONTRACTOR SHALL VERIFY IN THE FIELD THE EXACT LOCATION OF EACH OF THE ANCHOR BOLTS, THE POST ELEVATION AT THE TOP OF THE SUPPORTING CONCRETE AND SPAN LENGTH OF FRAME.
- B. PAYMENT FOR SUPPORT STRUCTURES FOR THE OVERHEAD SIGNS, LANE CONTROL DISPLAY SIGNALS AND FARADAY SHIELDS SHALL BE MADE AS DESCRIBED IN THE SPECIAL PROVISIONS.
- C. FARADAY SHIELD WIRES IN LONGITUDINAL DIRECTION SHALL BE INSTALLED SYMMETRICALLY ON EACH FARADAY SHIELD SUPPORT WITH A MAXIMUM OF 5 UNBALANCED OF 500' SPAN LENGTH. THE CONTRACTOR SHALL PROVIDE TEMPORARY BRACINGS FOR FARADAY SHIELD SUPPORT WHEN THE UNBALANCED WIRES EXCEED THE MAXIMUM DURING INSTALLATION.

7. SYMBOLS AND ABBREVIATIONS:

ABUT. - ABUTMENT
& - AND
@ - AT
B - BASELINE
BRG. - BEARING
CL., CLR. - CLEAR
CONN. - CONNECTION
CONT. - CONTINUOUS
DIAG. - DIAGONAL
DO. - DITTO
EQ. SPS. - EQUAL SPACES
EXIST. - EXISTING
FLEX. - FLEXIBLE
FM - FIXED MESSAGE

GRS - GALVANIZED RIGID STEEL
HEX. - HEXAGONAL
H.S. - HIGH STRENGTH
JB - JUNCTION BOX
JT. - JOINT
LTG. - LIGHTING
N.H. - NORTH HALAWA
PT - POINT OF TANGENT
RECT. - RECTANGULAR
STIFF. - STIFFENER
t., thk. - THICK
ULT. - ULTIMATE
VM - VARIABLE MESSAGE
WP - WEATHERPROOF
W/ - WITH

FOR DETAIL AS-BUILT INFORMATION
REFER TO CONSTRUCTION SUBMITTALS

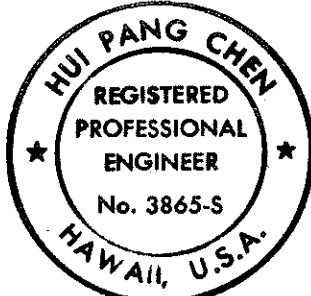


THIS WORK WAS PREPARED BY ME
OR UNDER MY SUPERVISION.
Hui Pang Chen

DATE	REVISION
STATE OF HAWAII DEPARTMENT OF TRANSPORTATION HIGHWAYS DIVISION	
GENERAL NOTES	
SUPPORT STRUCTURES INTERSTATE ROUTE H-3 F.A.I. PROJ. NO. I-H3-1(66)	
SCALE: NO SCALE	DATE: APR. 1992
SHEET No.SS1 OF 36 SHEETS	

FED. ROAD DIST. NO.	STATE	FED. AID PROJ. NO.	FISCAL YEAR	SHEET NO.	TOTAL SHEETS
HAWAII	HAW.	I-H3-1(66)	1992	365	440

NOTES:


1. HAIKU APPROACH FARADAY SHIELD/SIGN SUPPORT STRUCTURE SECTIONS SHOWN LOOKING UPSTATION SHEET NOS. SS9 THRU SS14 EXCEPT SECTION E & SECTION F SS3/SS12
2. HAIKU APPROACH FARADAY SHIELD SUPPORT STRUCTURES ARE RADIAL TO BASELINE EXCEPT AS SHOWN OTHERWISE ON LAYOUT PLAN.
3. FARADAY SHIELD STRUCTURE INSTALLED.

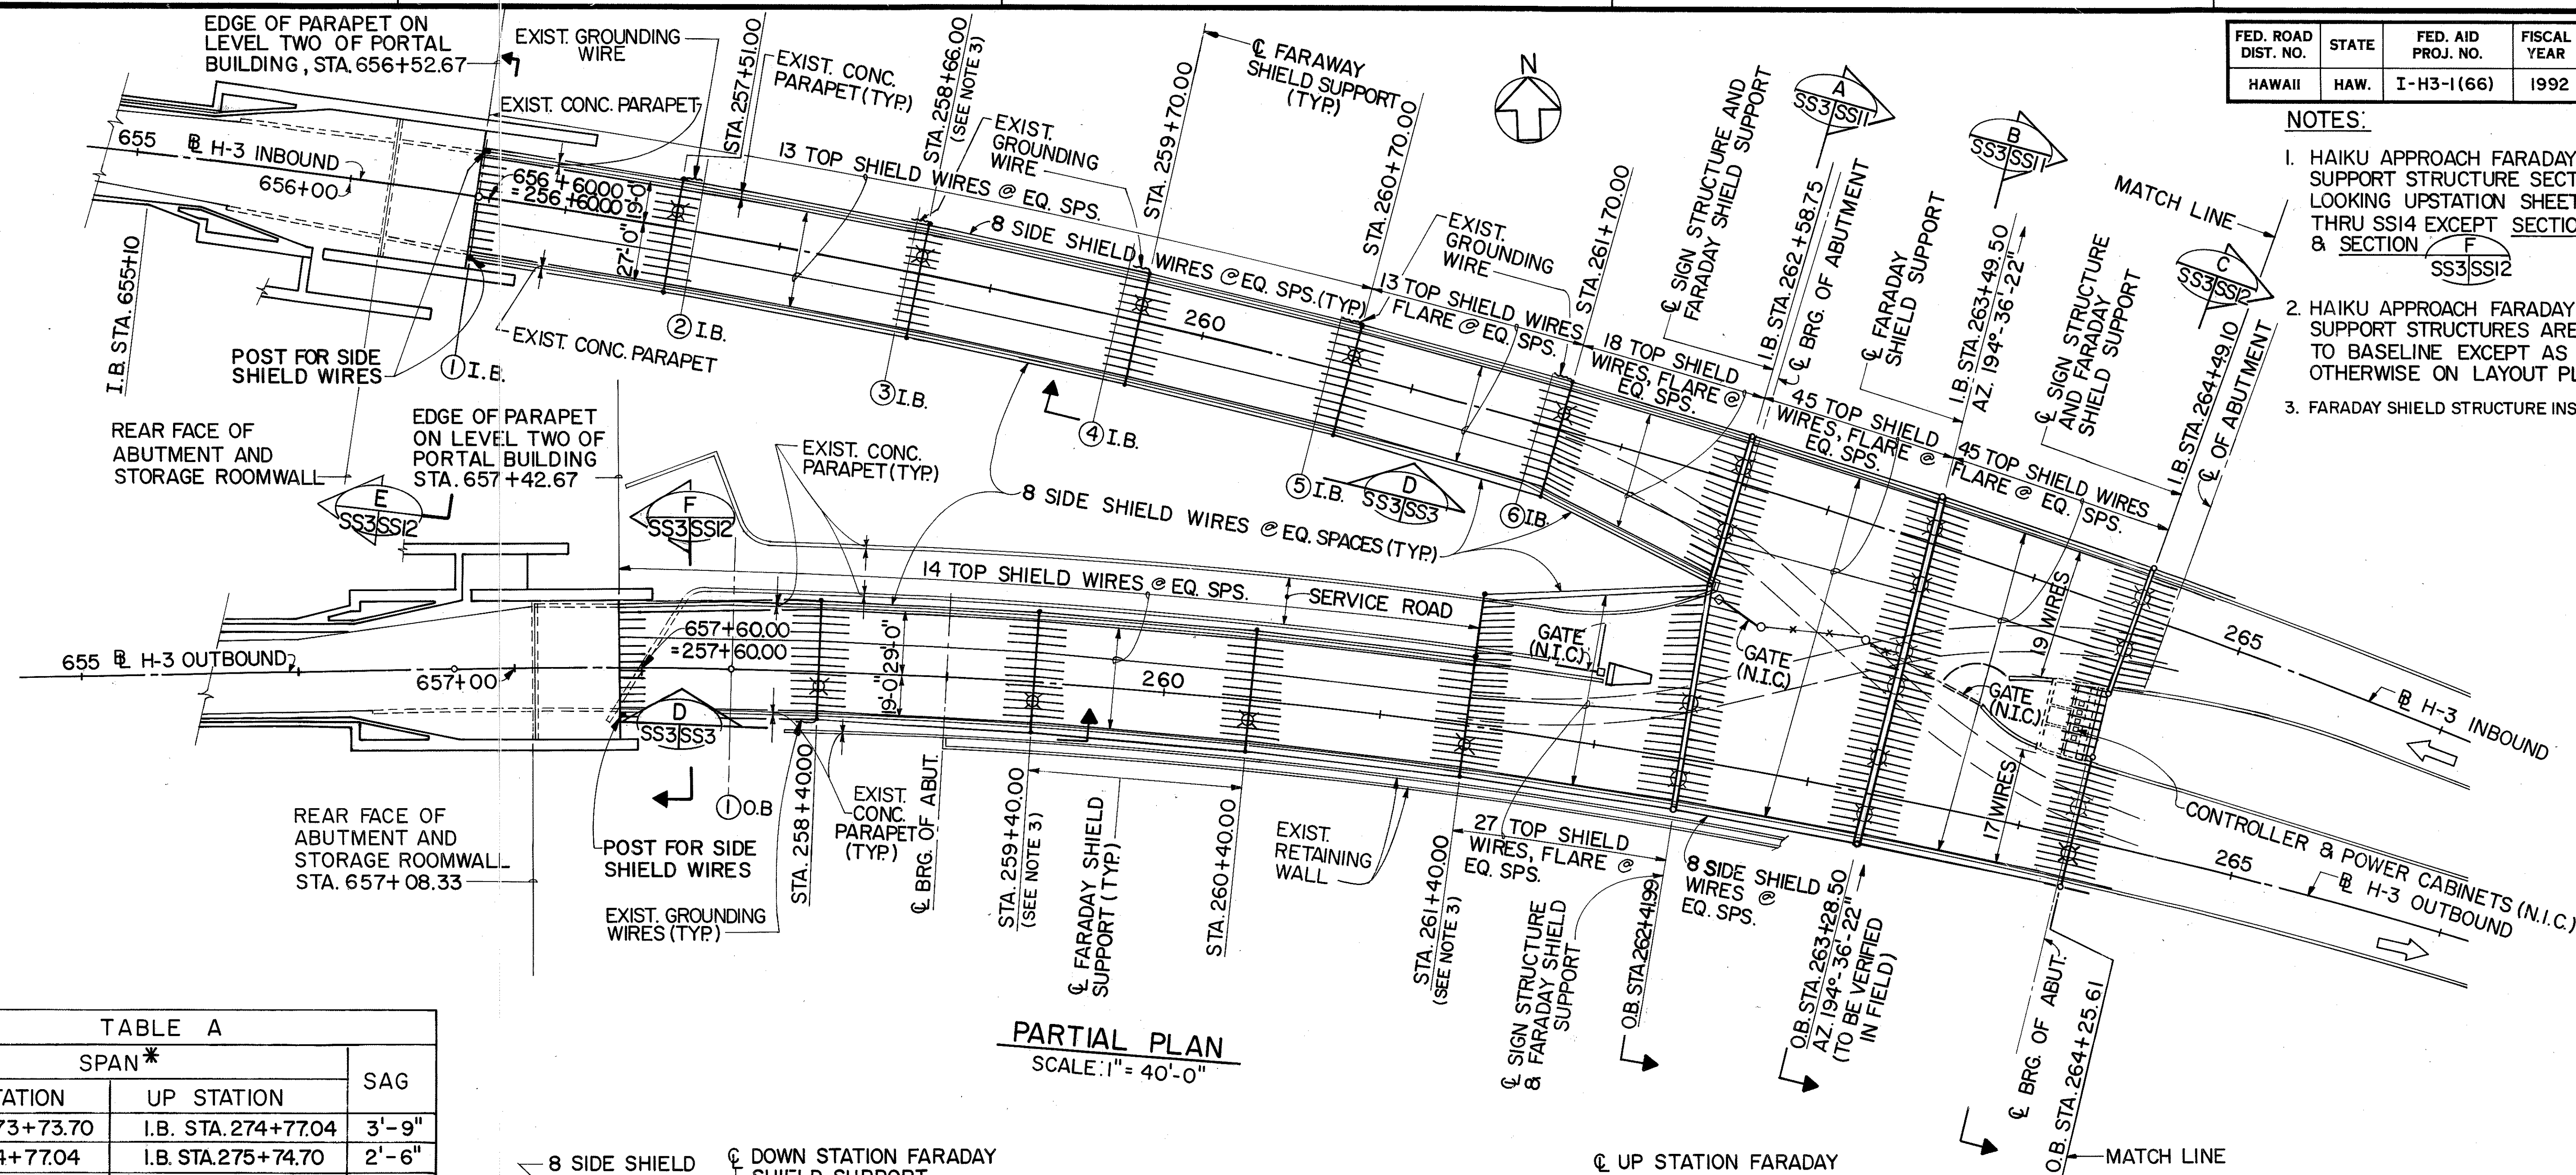


PARTIAL PLAN
SCALE: 1" = 40'-0"

TABLE A		
SPAN *		SAG
DOWN STATION	UP STATION	
I.B. STA. 273+73.70	I.B. STA. 274+77.04	3'-9"
I.B. STA. 274+77.04	I.B. STA. 275+74.70	2'-6"
I.B. STA. 284+14.70	I.B. STA. 285+05.53	2'-6"
I.B. STA. 285+05.53	I.B. STA. 285+97.07	3'-9"
I.B. STA. 285+97.07	I.B. STA. 286+94.70	2'-9"
I.B. STA. 295+53.70	I.B. STA. 296+53.70	2'-6"
I.B. STA. 296+53.70	I.B. STA. 297+57.20	3'-9"
O.B. STA. 273+70.11	O.B. STA. 274+61.54	3'-9"
O.B. STA. 274+61.54	O.B. STA. 275+59.28	2'-9"
O.B. STA. 276+48.28	O.B. STA. 277+41.50	2'-6"
O.B. STA. 284+78.28	O.B. STA. 285+74.49	2'-9"
O.B. STA. 285+74.49	O.B. STA. 286+63.49	3'-9"
O.B. STA. 286+63.49	O.B. STA. 287+59.28	2'-9"
O.B. STA. 297+66.79	O.B. STA. 298+62.28	3'-9"
O.B. STA. 298+62.28	O.B. STA. 299+57.28	2'-6"


* REQUIRES SPACER, SEE SHEET NO. SS32 FOR DETAIL

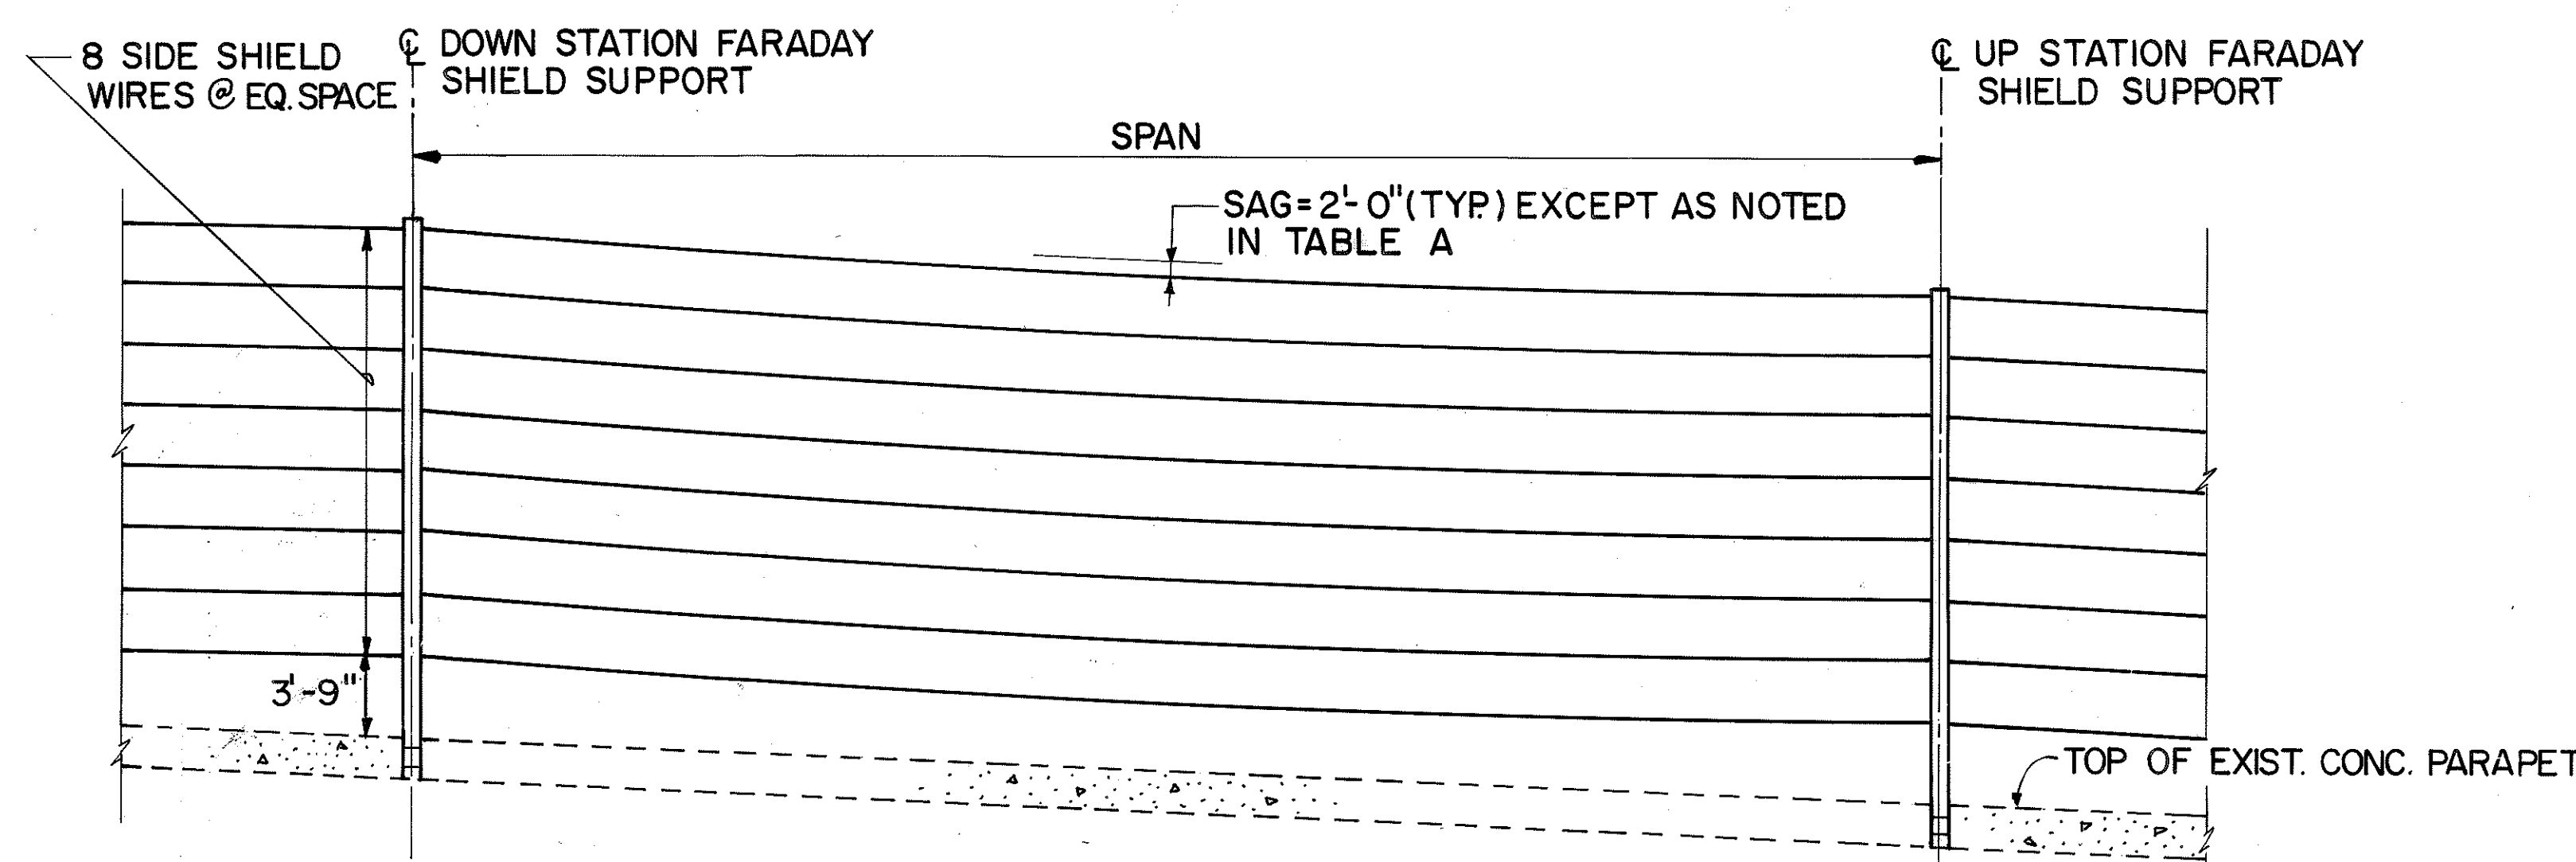

VIEW D
SS3/SS3
TYPICAL PARTIAL ELEVATION FOR FARADAY SHIELD
N.T.S.

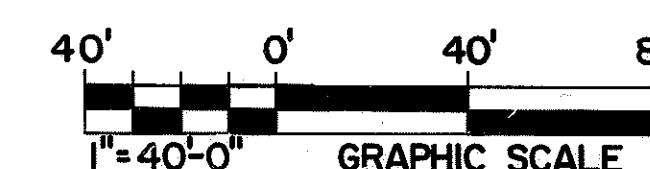

THIS WORK WAS PREPARED BY ME
OR UNDER MY SUPERVISION.

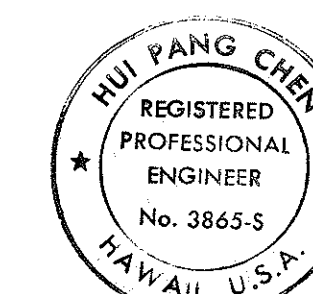


LEGEND

- DENOTES LOCATION OF FUTURE LUMINAIRE.

12/29/93	REV. DISTANCE FROM SIDE SHIELD WIRE TO TOP OF PARAPET (VIEW 'D') PER DCN 66-027
10/26/93	REVISED TABLE 'A' PER DCN 66-023
DATE	REVISION



STATE OF HAWAII DEPARTMENT OF TRANSPORTATION HIGHWAYS DIVISION	
HAIKU APPROACH - LAYOUT PLAN 1 SUPPORT STRUCTURES	
INTERSTATE ROUTE H-3 FAI PROJ. NO. I-H3-1 (66)	
SCALE: AS SHOWN	DATE: APR. 1992
SHEET NO. SS3 OF 36 SHEETS	

FED. ROAD DIST. NO.	STATE	FED. AID PROJ. NO.	FISCAL YEAR	SHEET NO.	TOTAL SHEETS
HAWAII	HAW.	I-H3-1(66)	1992	367	440

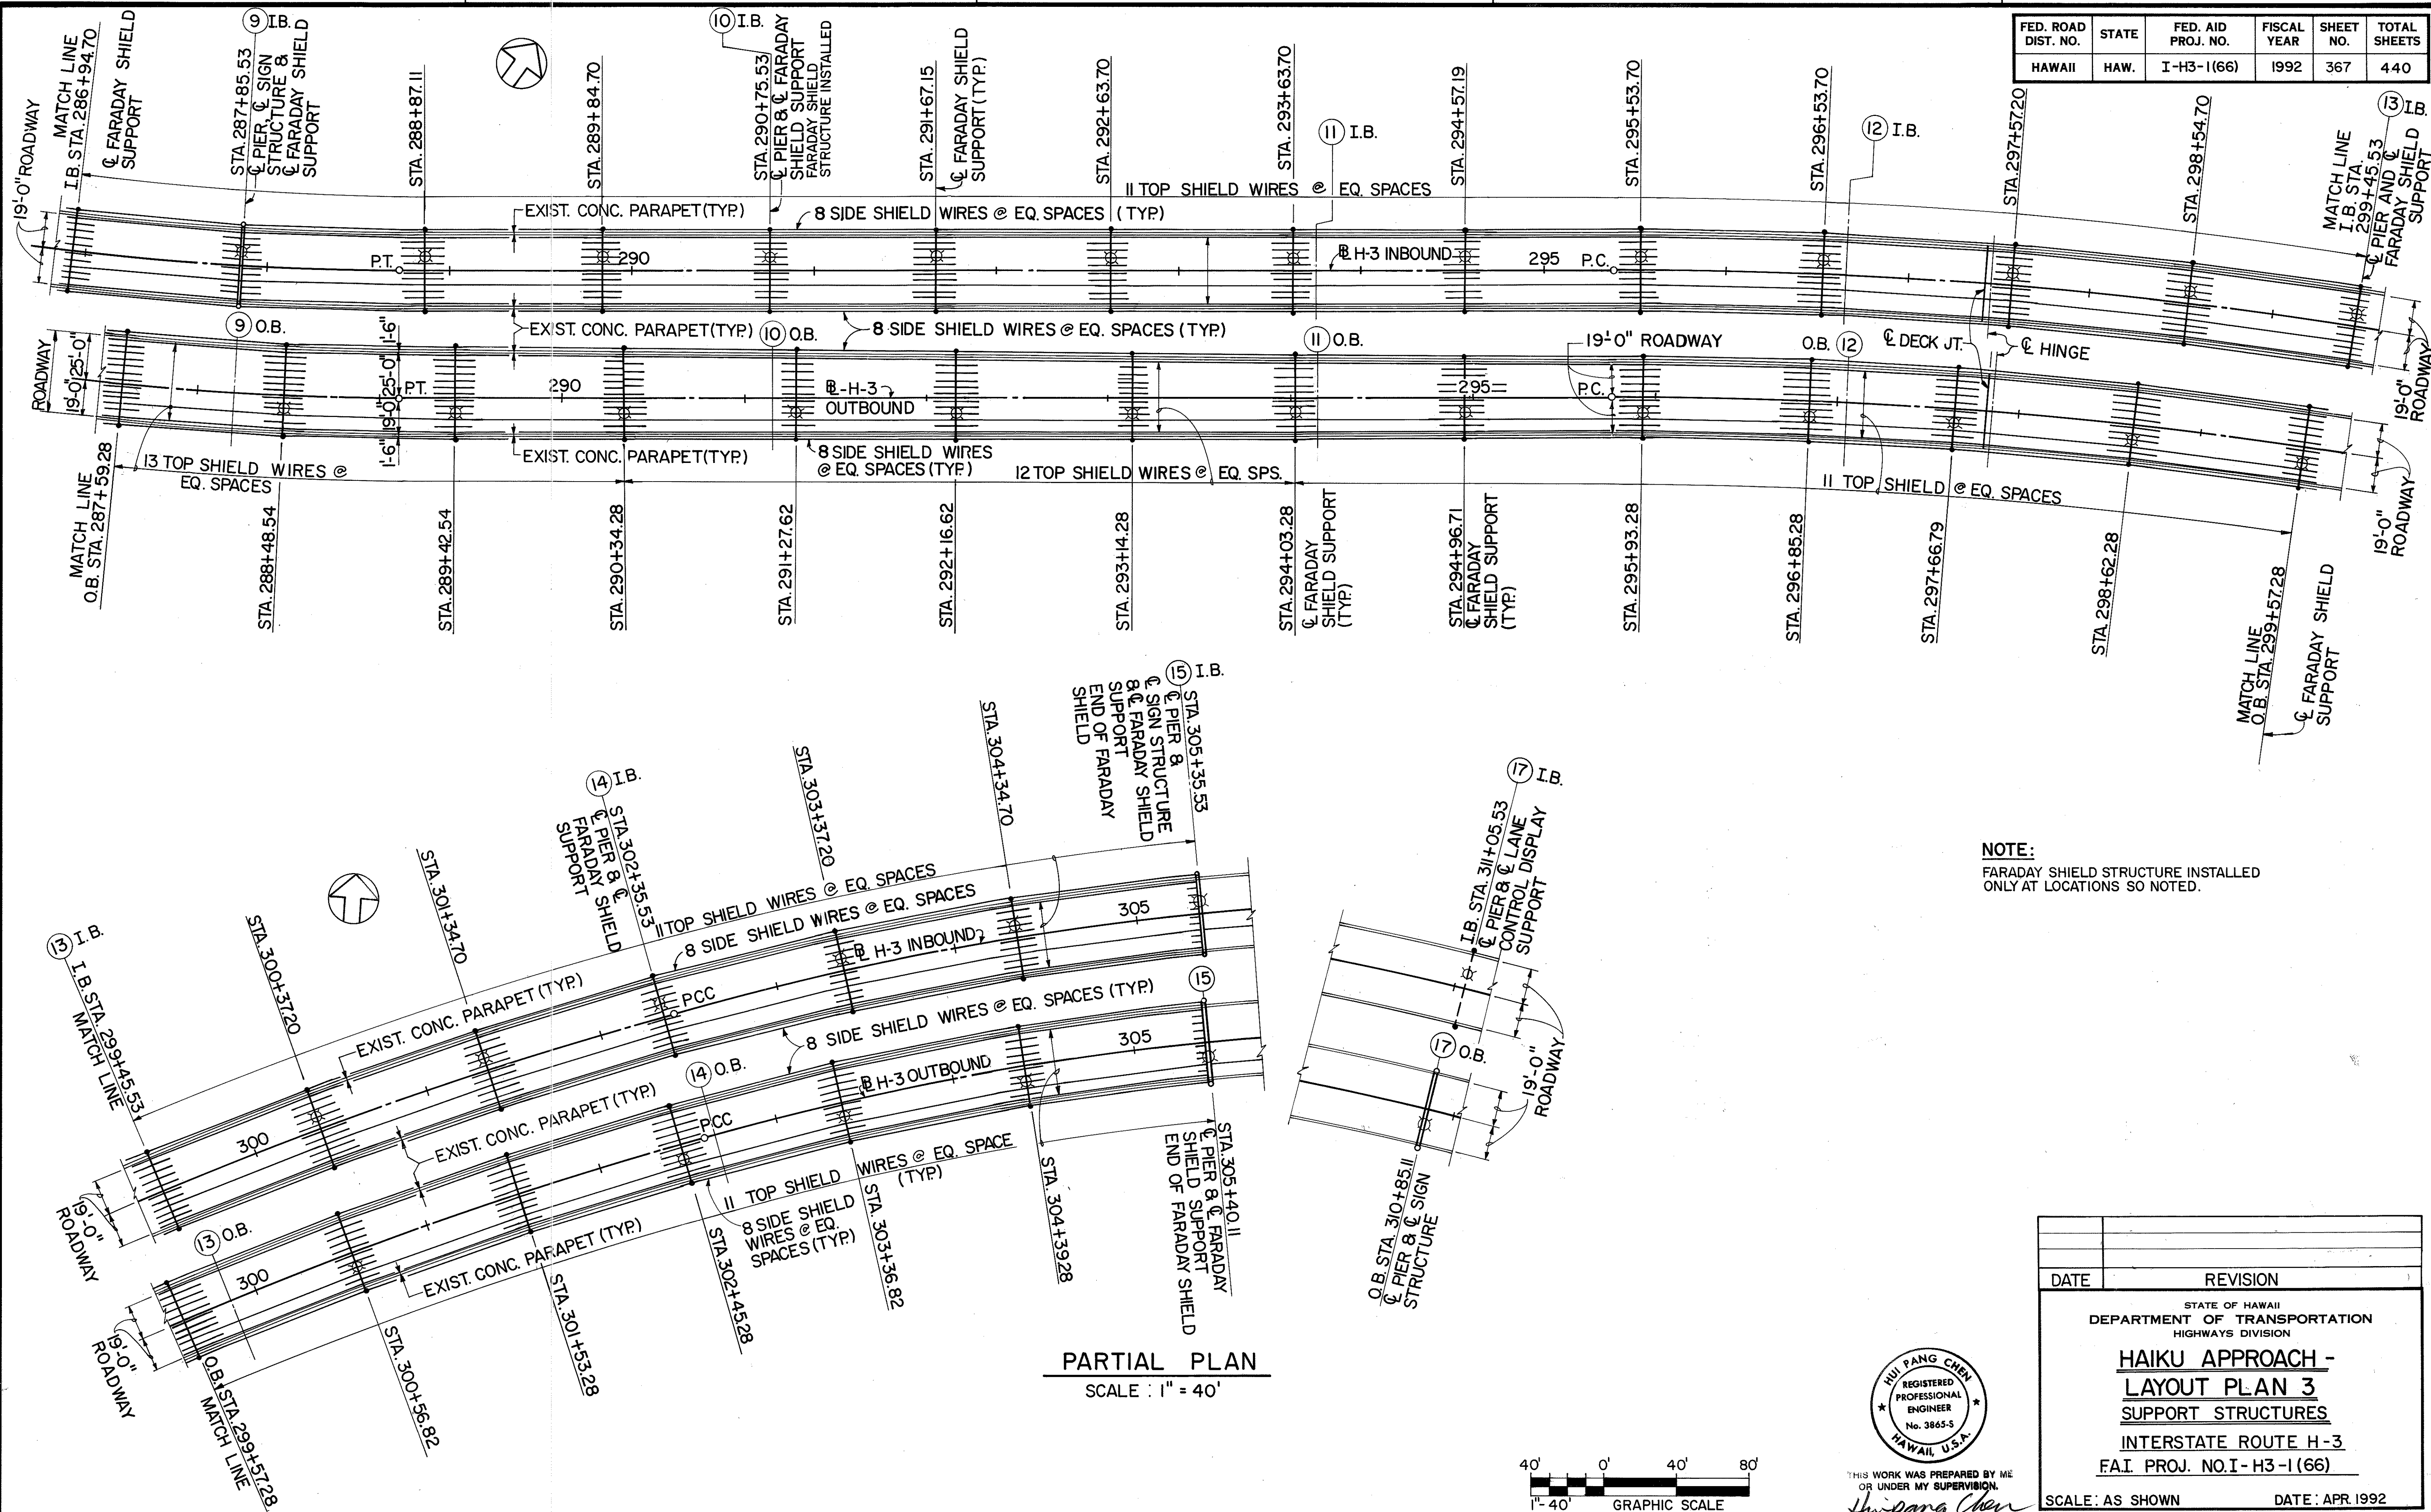

NOTE:
FARADAY SHIELD STRUCTURE INSTALLED ONLY AT LOCATIONS SO NOTED.

PARTIAL PLAN
SCALE: 1" = 40'

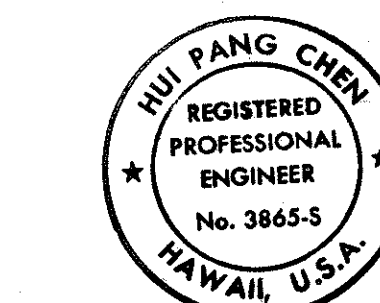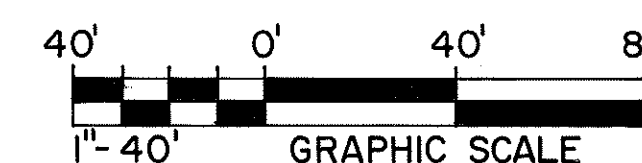





THIS WORK WAS PREPARED BY ME
OR UNDER MY SUPERVISION.

Hui Pang Chen



DATE	REVISION
STATE OF HAWAII DEPARTMENT OF TRANSPORTATION HIGHWAYS DIVISION	
HAIKU APPROACH - LAYOUT PLAN 3 SUPPORT STRUCTURES	
INTERSTATE ROUTE H-3 FAI PROJ. NO. I-H3-1(66)	
SCALE: AS SHOWN	DATE: APR. 1992
SHEET No. SS5 OF 36 SHEETS	

ORIGINAL PLAN	DATE	7/90
DESIGNED BY	7/90	
QUANTITIES BY	7/90	
CHECKED BY	7/90	

FED. ROAD DIST. NO.	STATE	FED. AID PROJ. NO.	FISCAL YEAR	SHEET NO.	TOTAL SHEETS
HAWAII	HAW.	I-H3-1(66)	1992	368	440

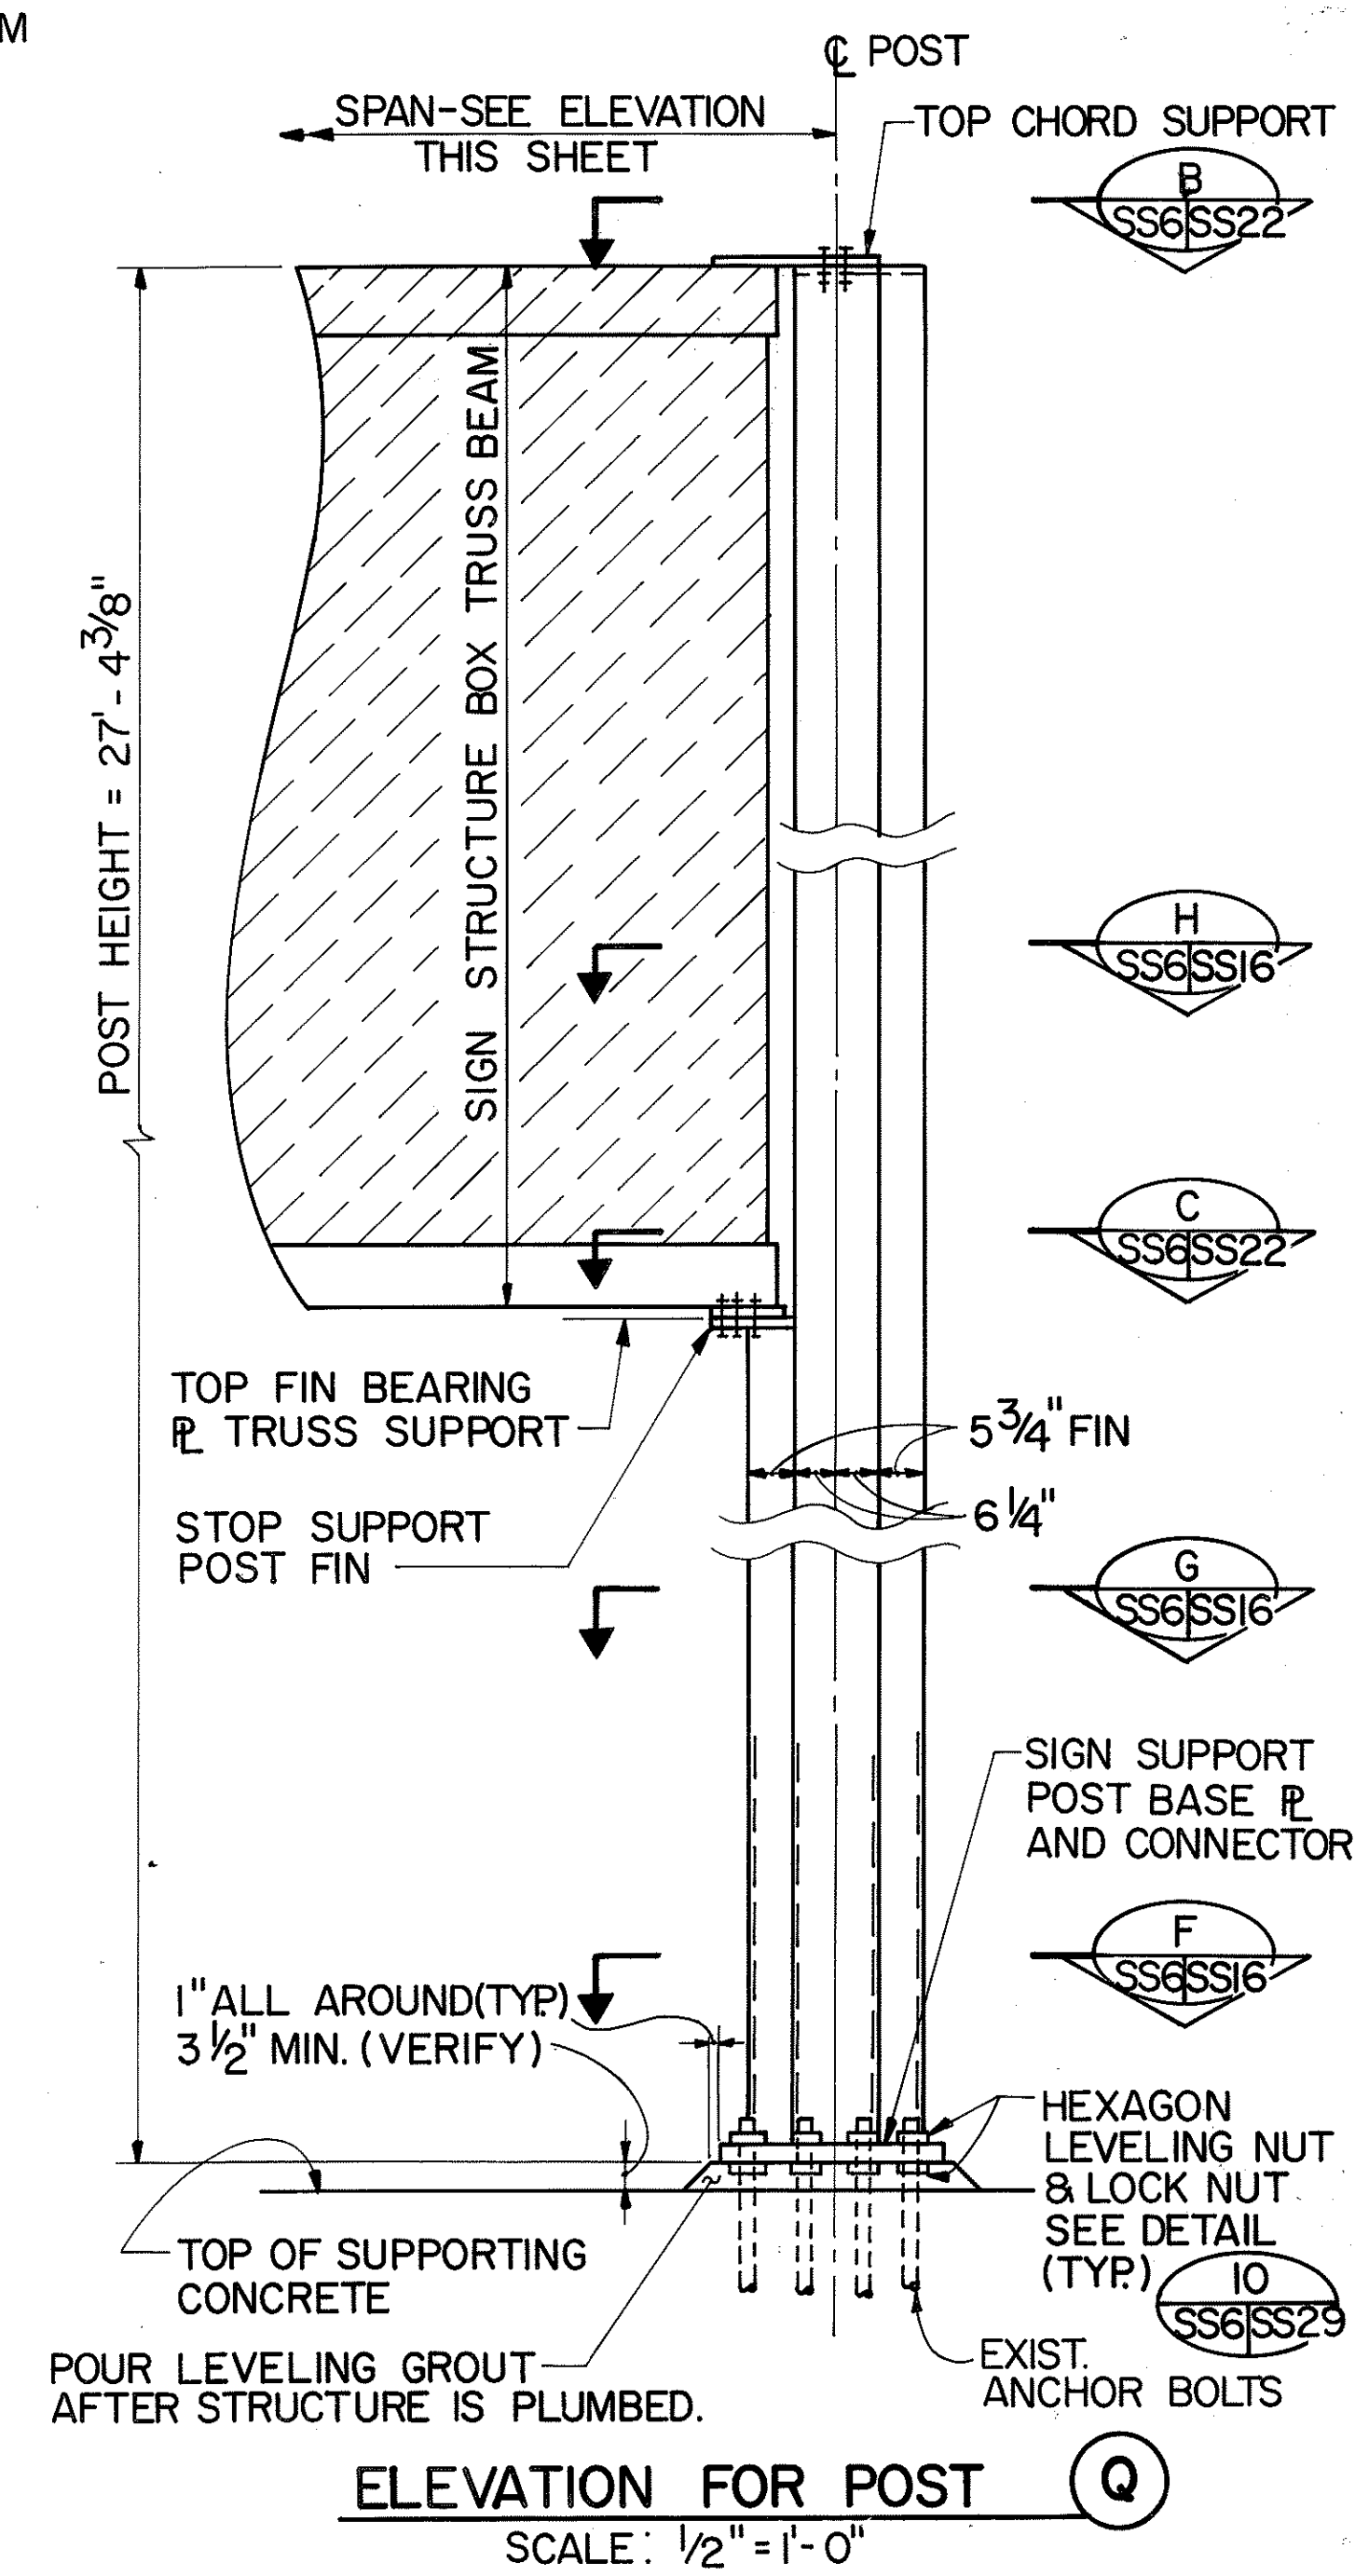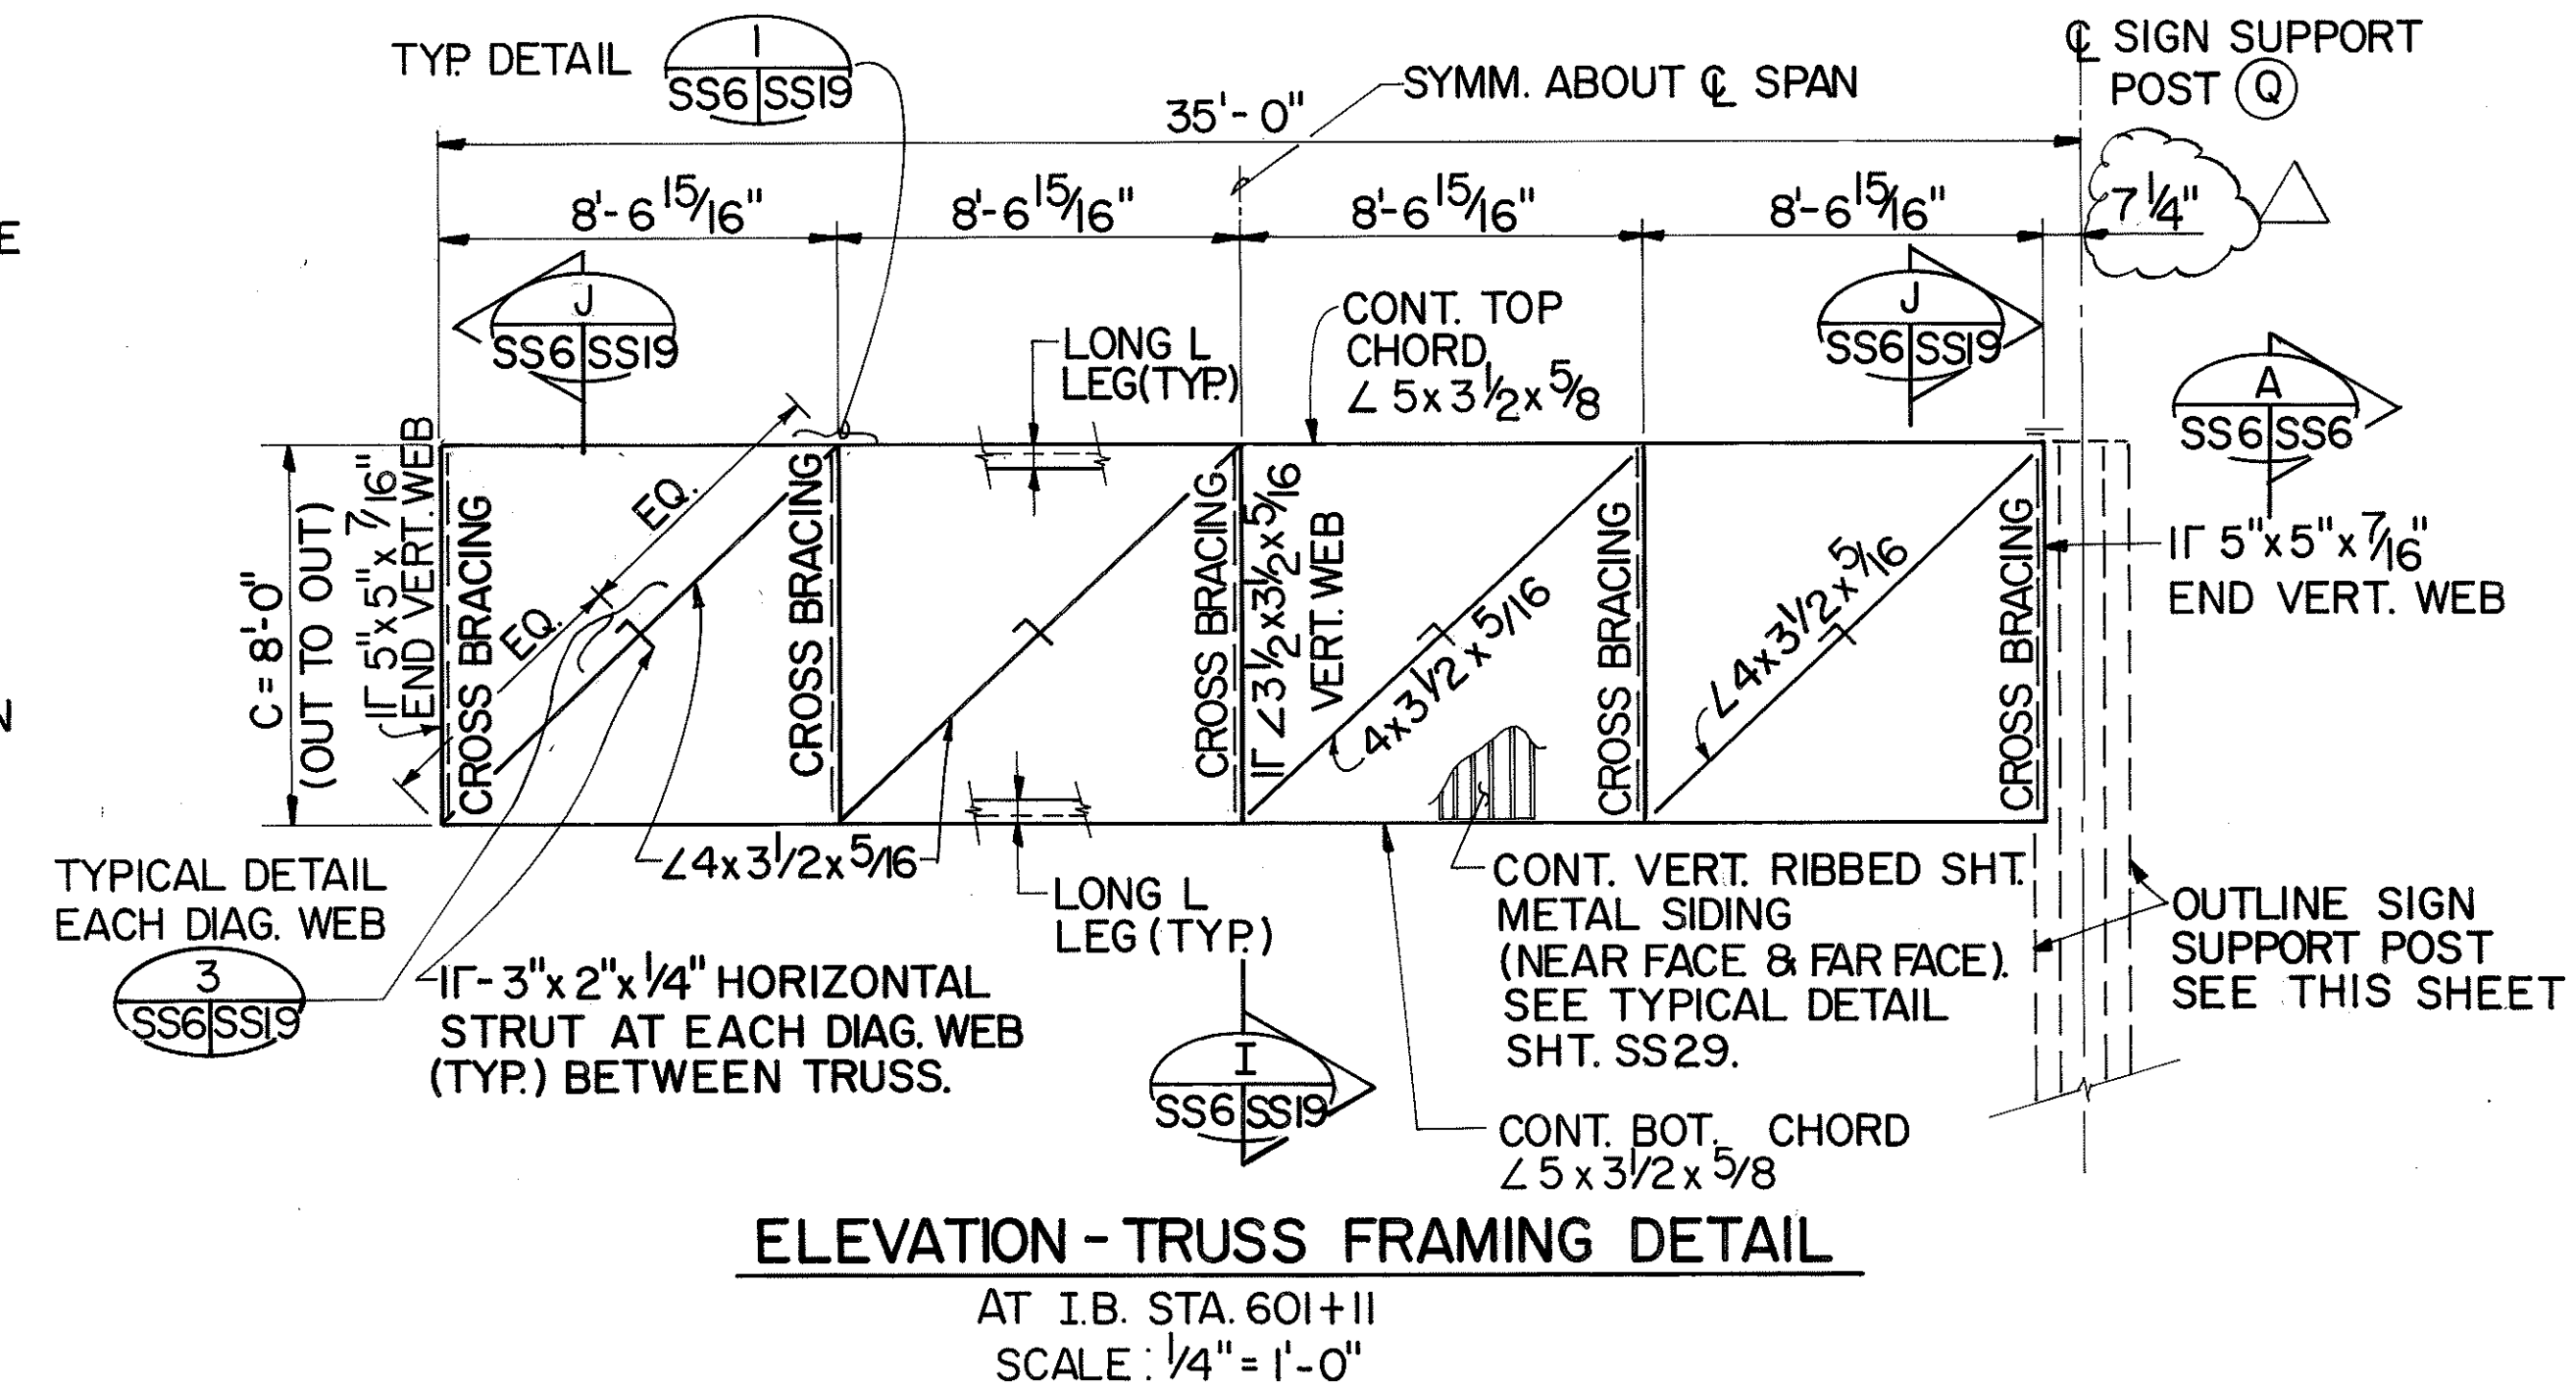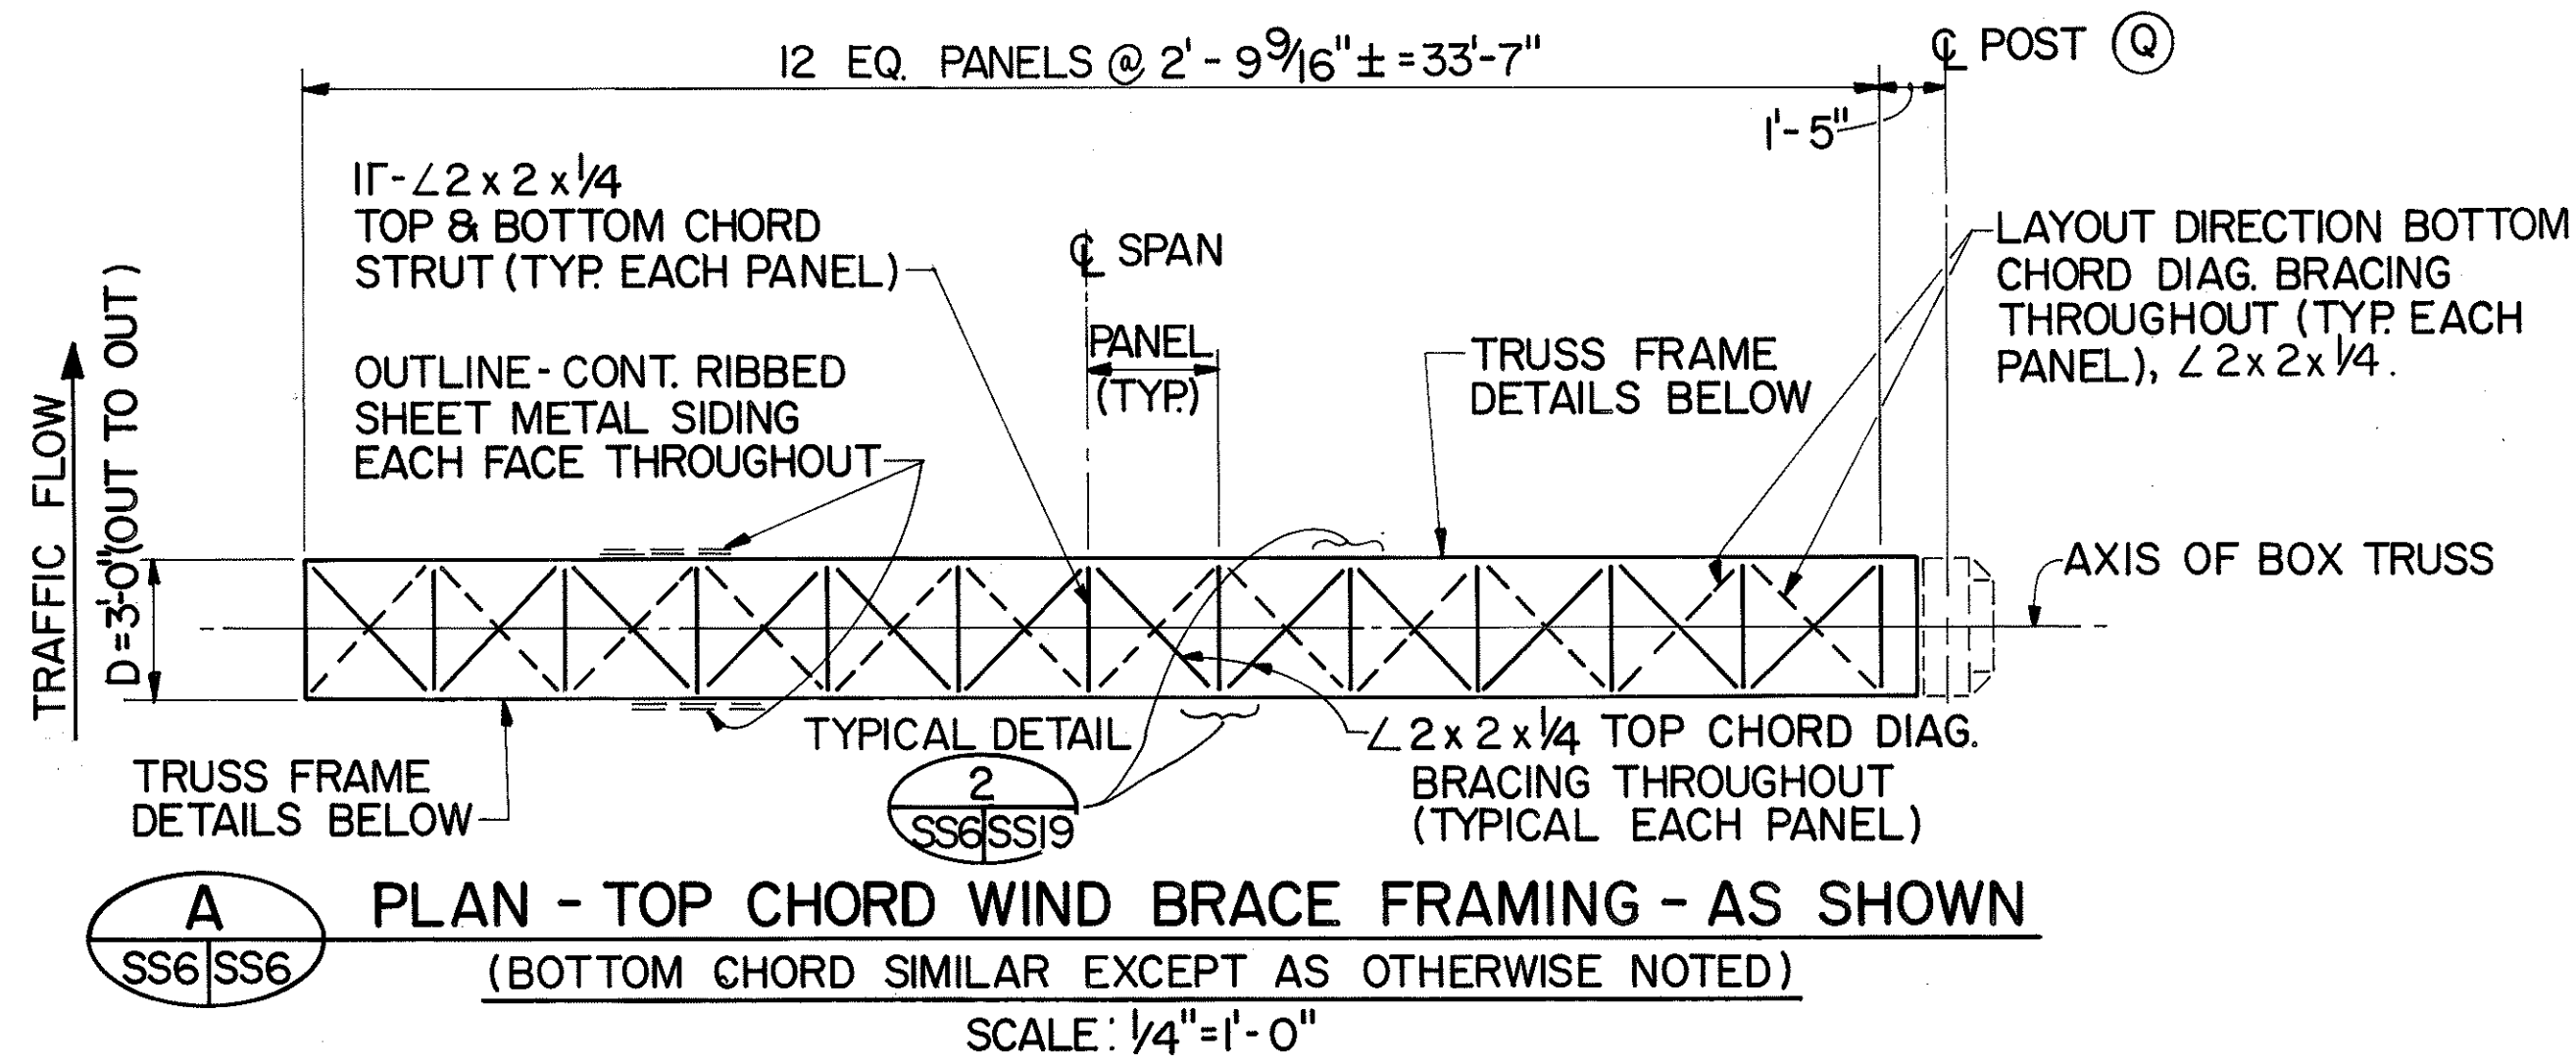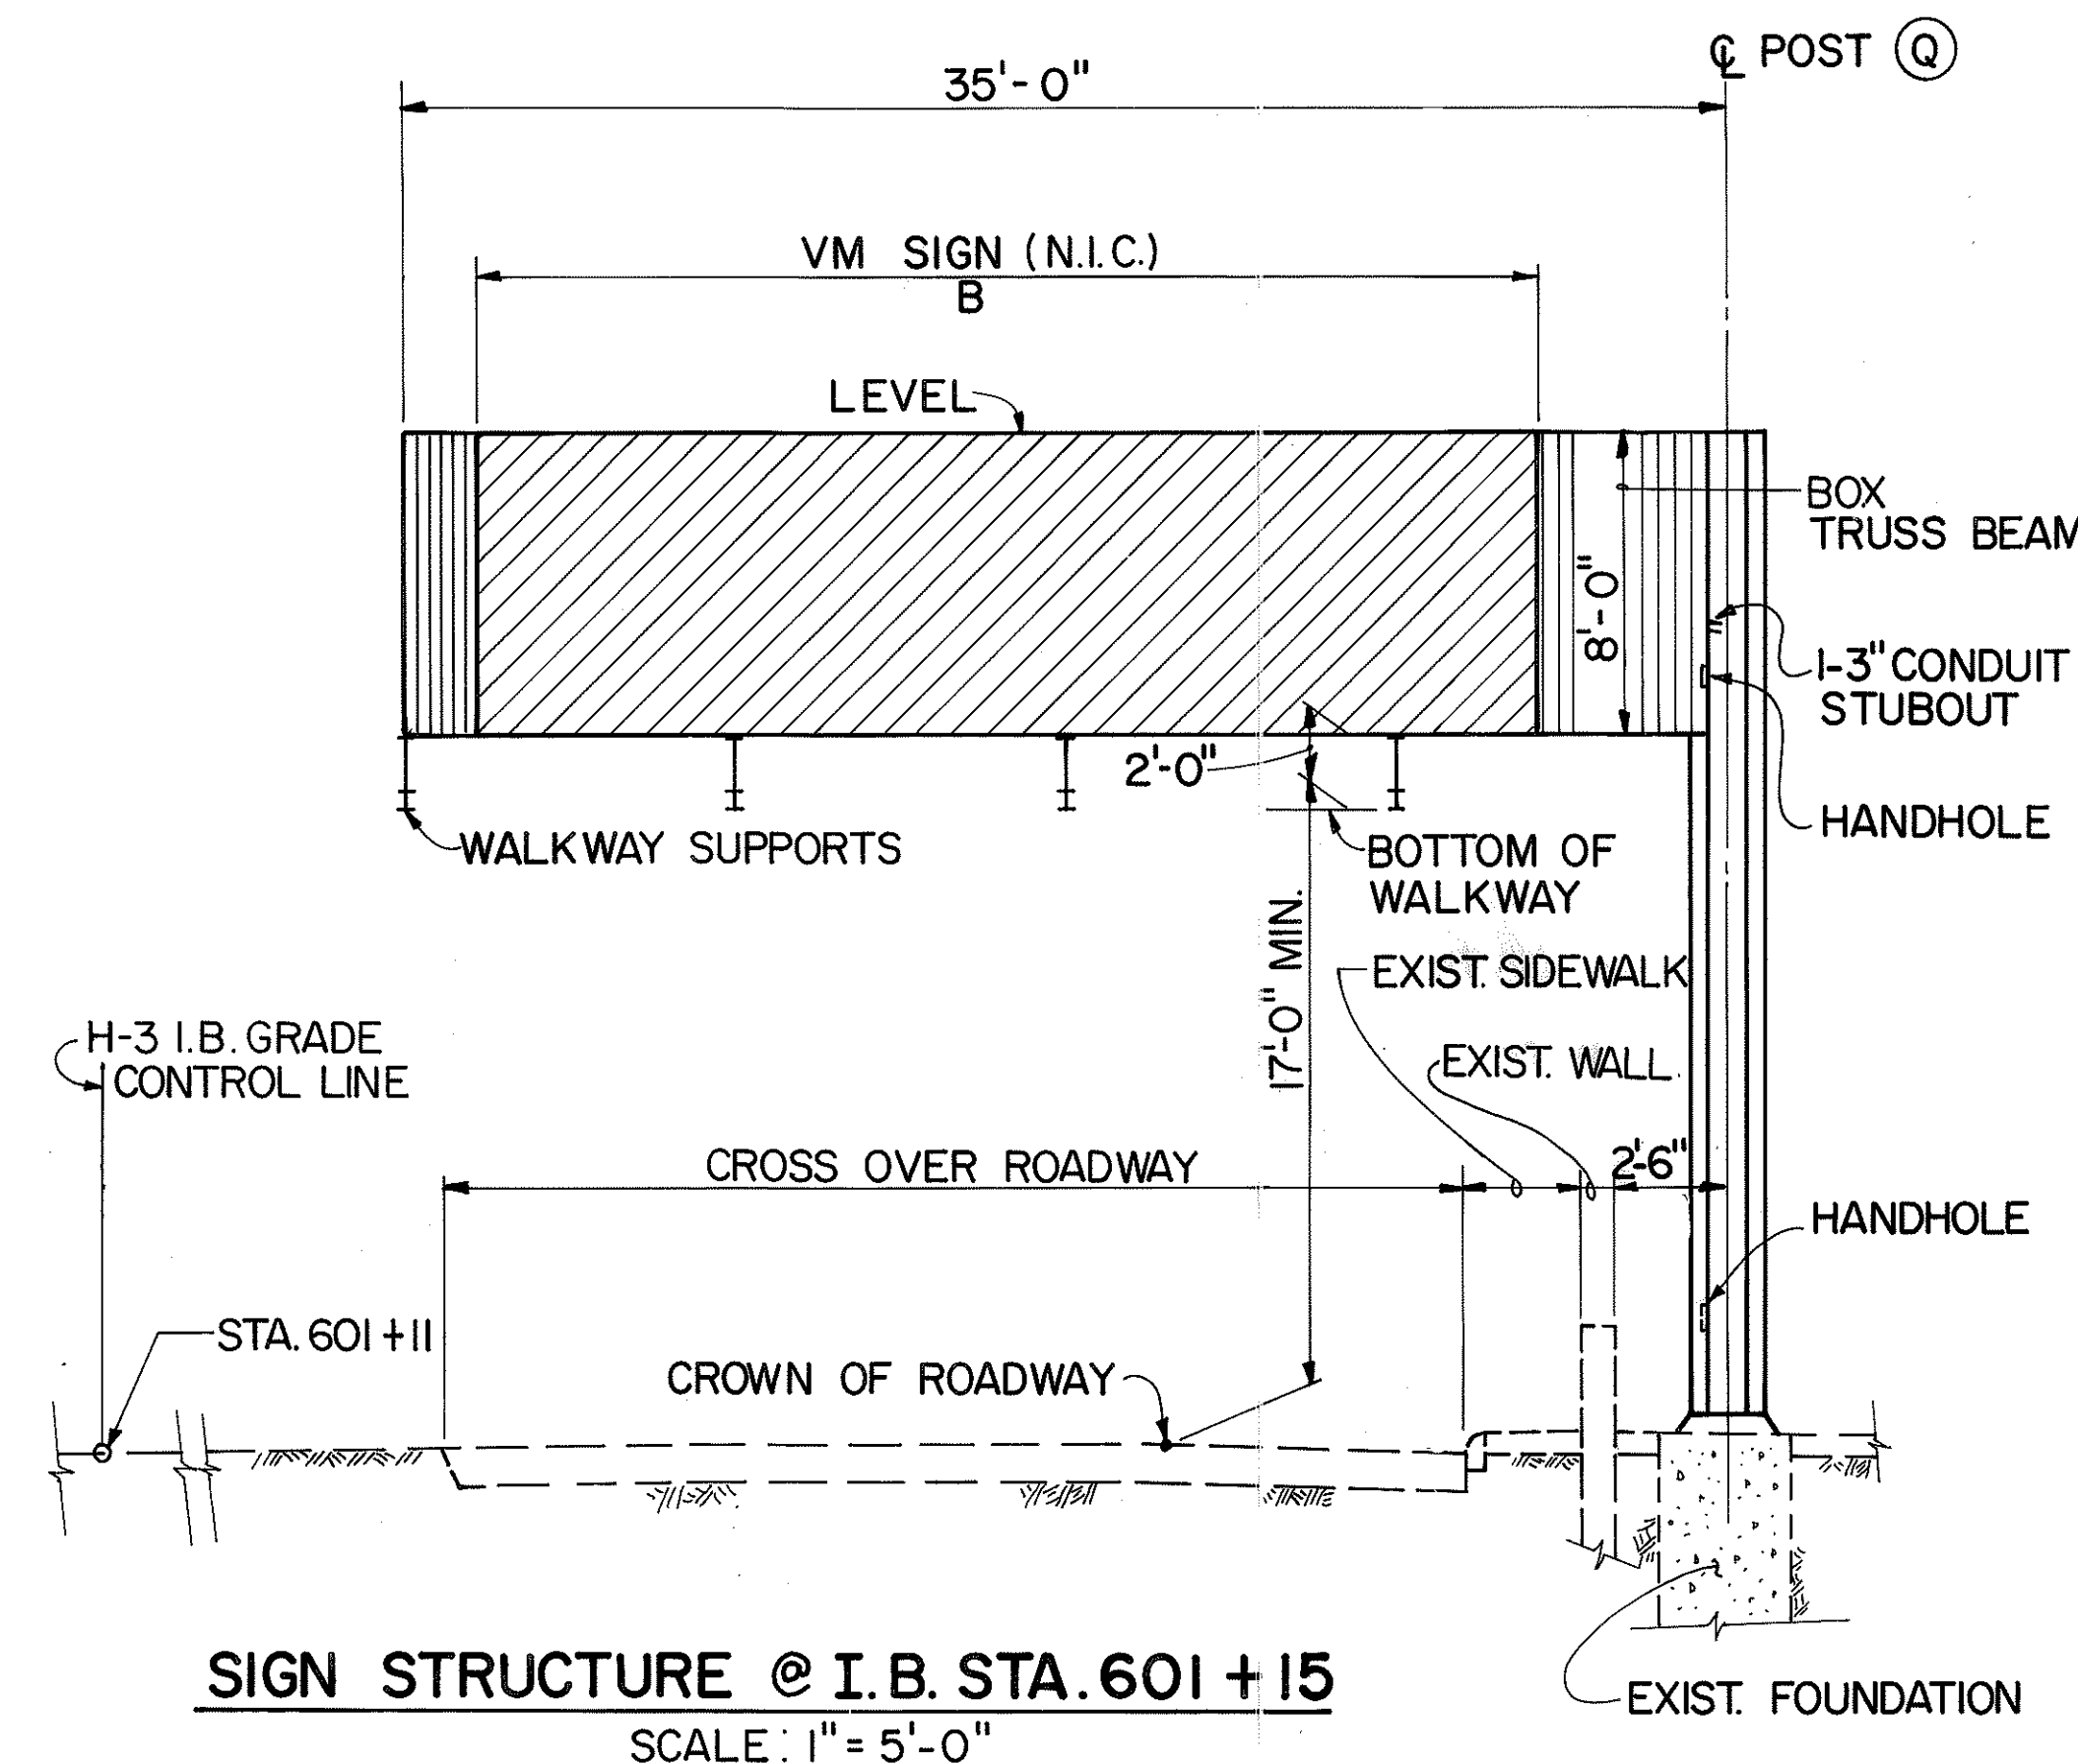

- NOTES:**
- FOR LOCATIONS OF SIGNS AND WALKWAY SUPPORTS, SEE SHEET NO. SS25.
 - FOR BOX TRUSS CONNECTION DETAILS, SEE SHEET NO. SS19.

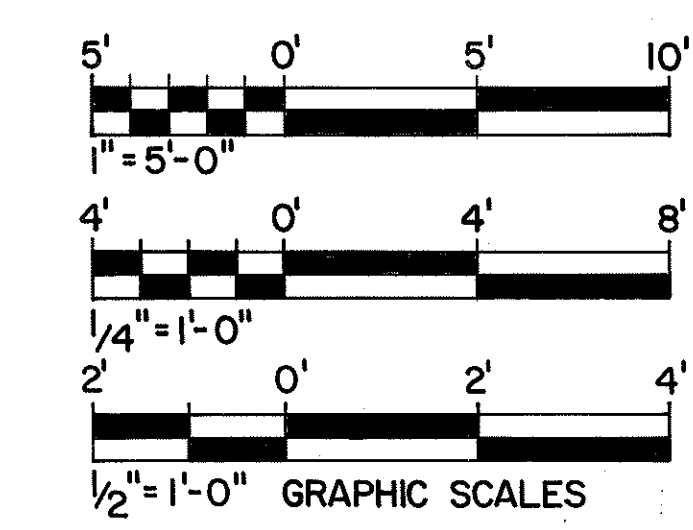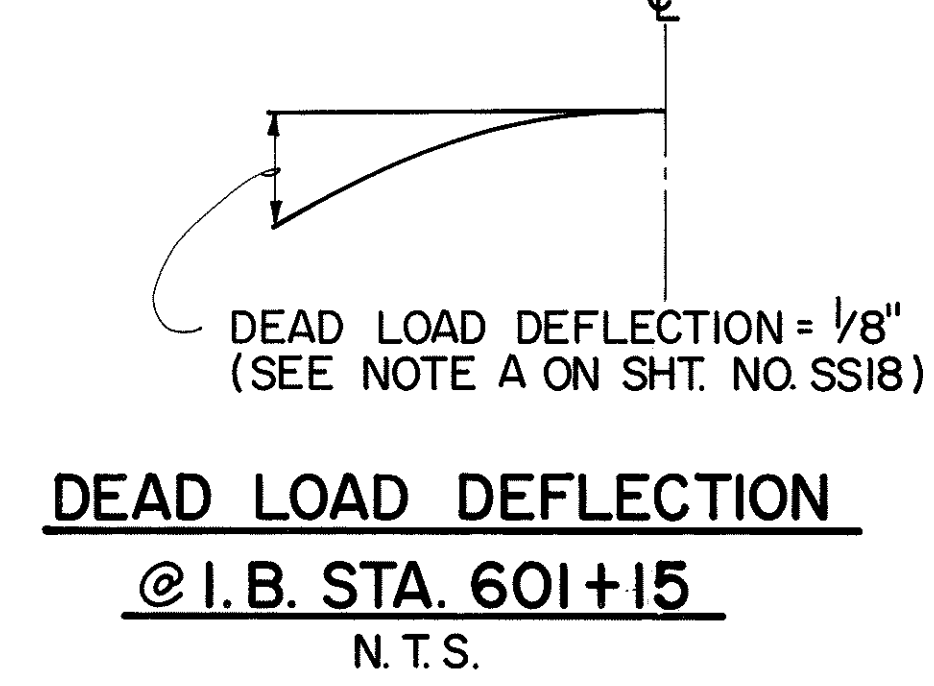


THIS WORK WAS PREPARED BY ME OR UNDER MY SUPERVISION.
Hui Pang Chen
REGISTERED PROFESSIONAL ENGINEER
No. 3865-S
HAWAII, U.S.A.

2/24/94	CLARIFY DIMENSIONS PER DCN 66 - 036
DATE	REVISION
STATE OF HAWAII DEPARTMENT OF TRANSPORTATION HIGHWAYS DIVISION HALAWA APPROACH-SECTION I SUPPORT STRUCTURES INTERSTATE ROUTE H-3 F.A.I. PROJ. NO. I-H3-1 (66) SCALE: AS SHOWN DATE: APR. 1992 SHEET No. SS6 OF 36 SHEETS	


DATE	1/92
DESIGNED BY	S. CHUN
CHECKED BY	J. F. CHEN
ORIGINAL PLAN	
NOTE BOOK	

ORIGINAL PLAN	SURVEY PLOTTED BY	DATE
	DRAWN BY <u>K. MALALUN</u>	<u>1/90</u>
NOTE BOOK	TRACED BY _____	
	DESIGNED BY <u>K. MADA</u>	<u>1/90</u>
	QUANTITIES BY <u>S. CHIN</u>	<u>3/92</u>
No. _____	CHECKED BY <u>S. CHIN</u>	<u>1/90</u>

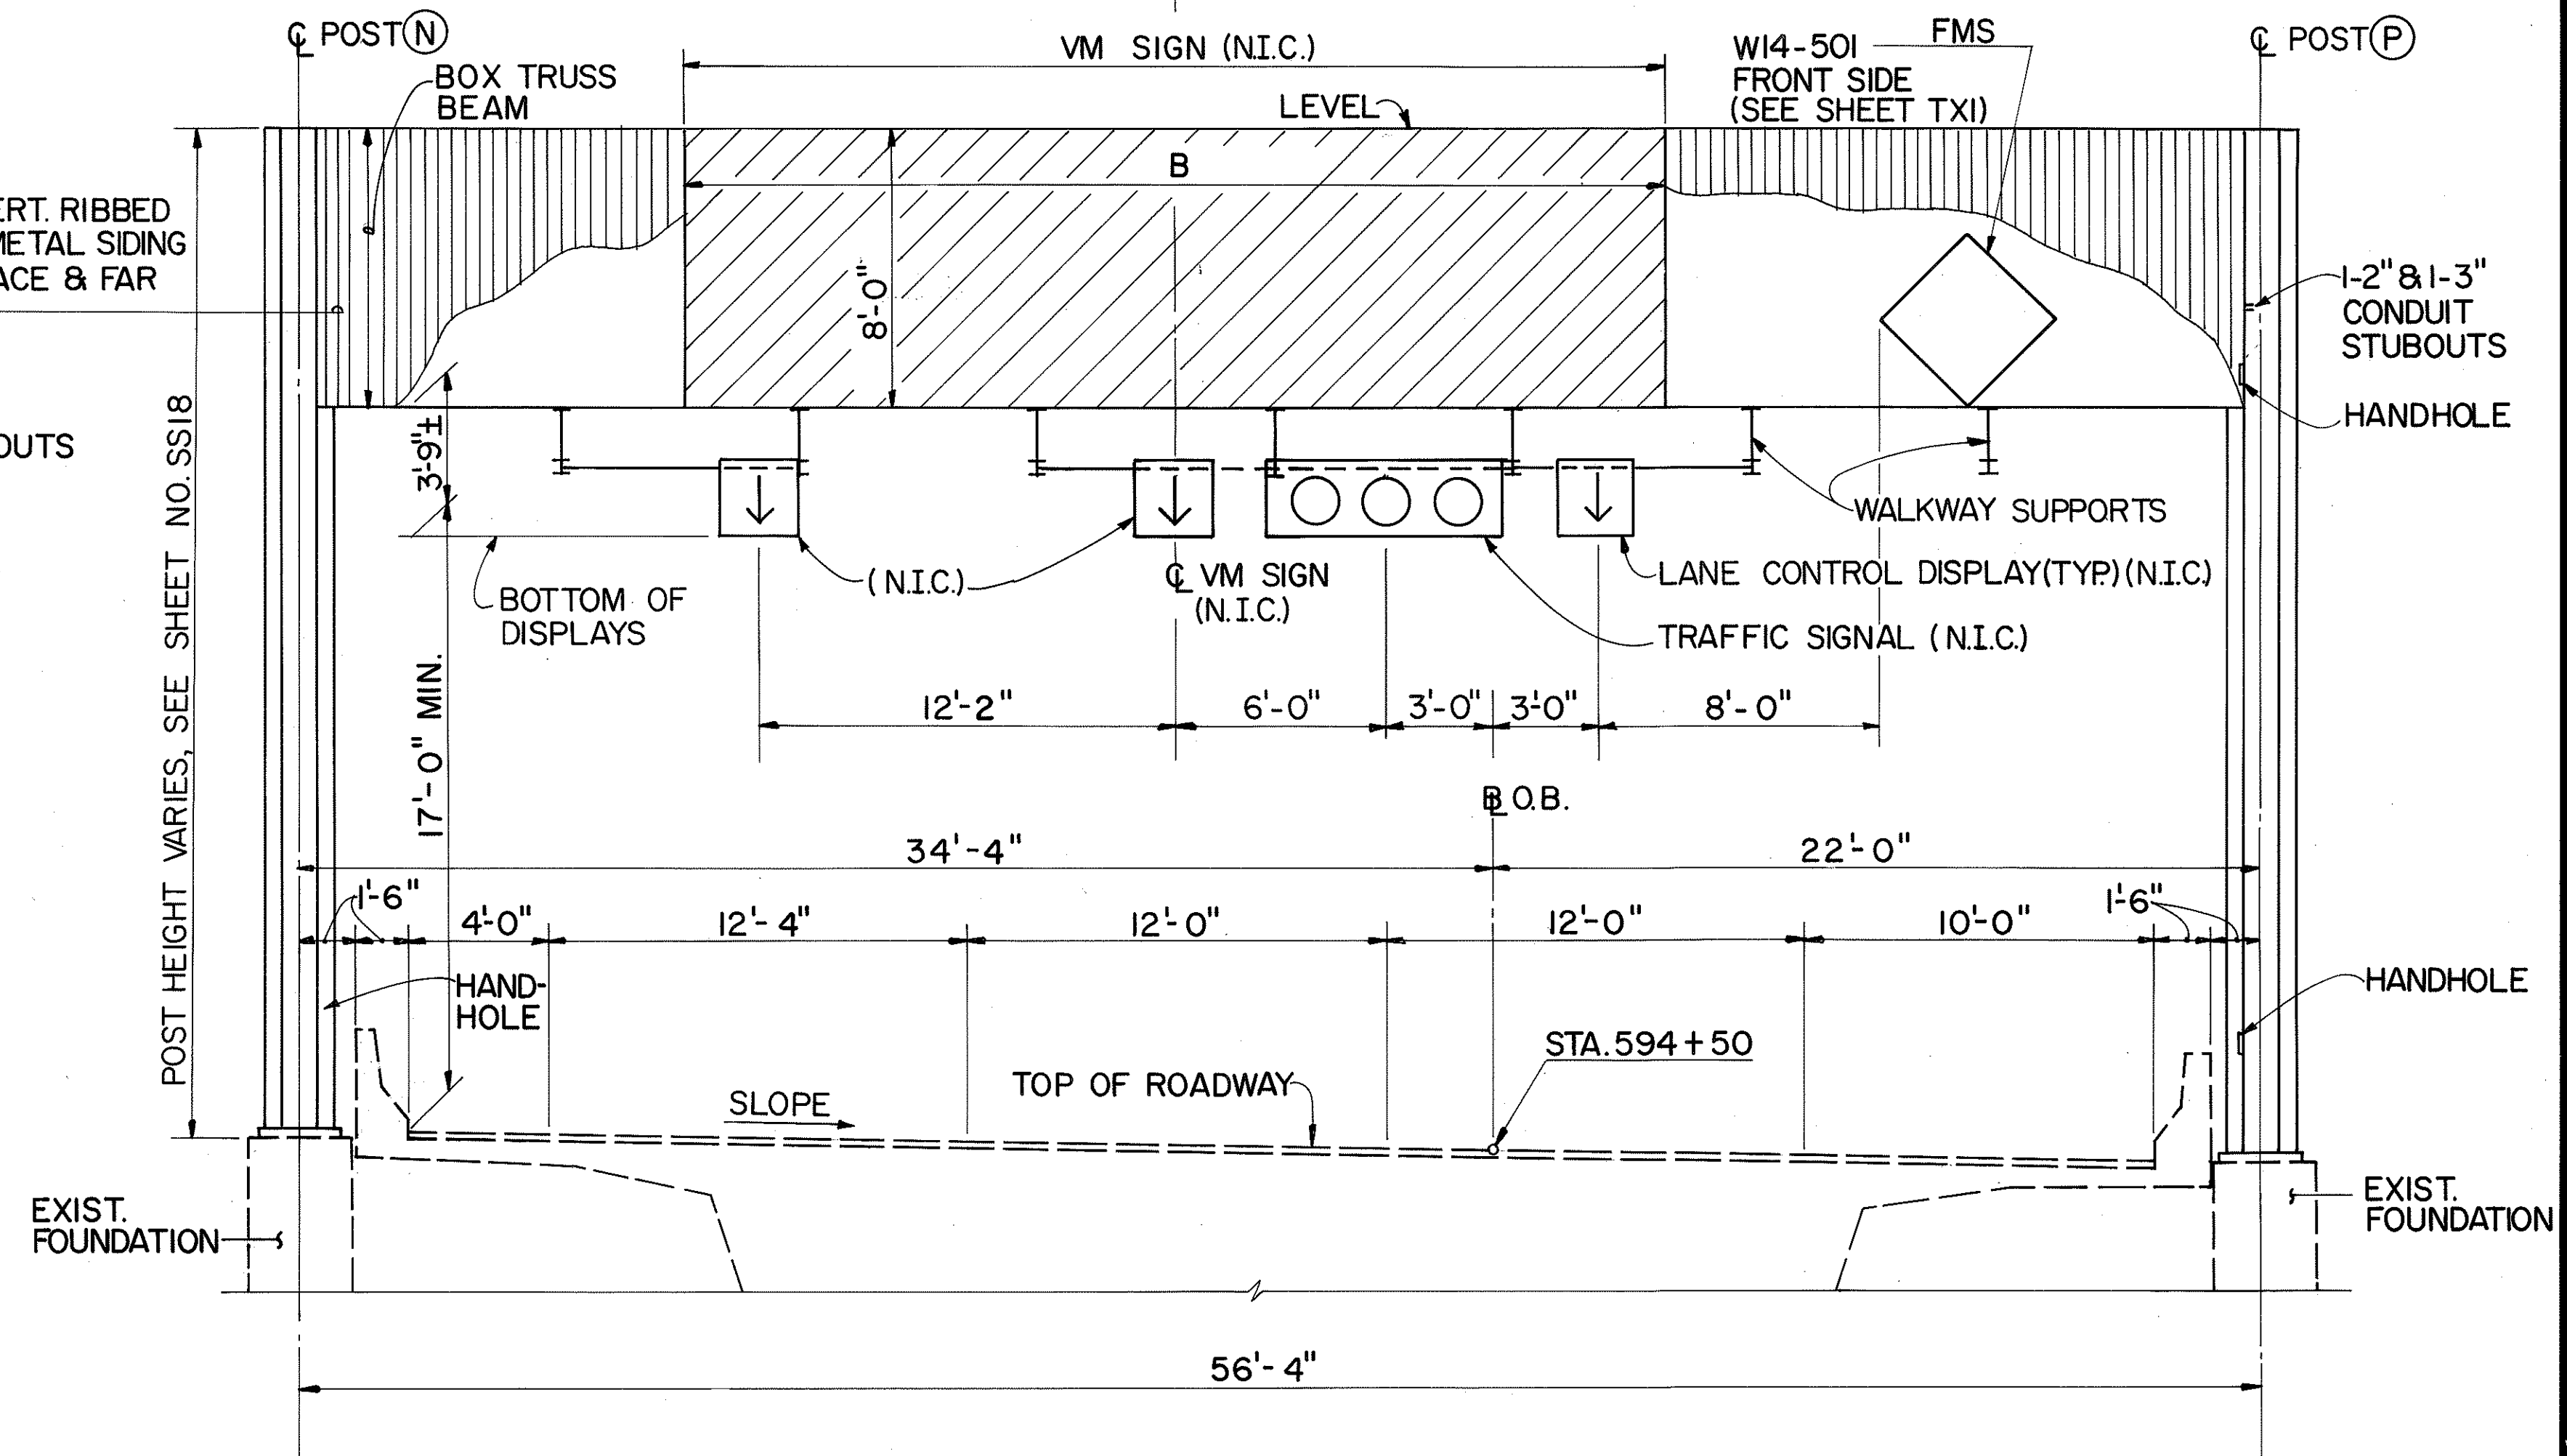

SIGN STRUCTURE @ O.B. STA. 594+50
SCALE: 1/4" = 1'-0"


1/4" = 1'-0" GRAPHIC SCALE

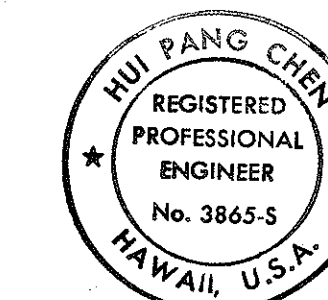

THIS WORK WAS PREPARED BY ME
OR UNDER MY SUPERVISION.



369

ORIGINAL PLAN	SURVEY PLOTTED BY _____	DATE _____
	DRAWN BY <u>D. NYUNG</u>	_____
	TRACED BY _____	_____
NOTE BOOK	DESIGNED BY <u>K. WADA</u>	_____
	QUANTITIES BY <u>S. CHUN</u>	_____
No. _____	CHECKED BY <u>S. CHUN</u>	_____

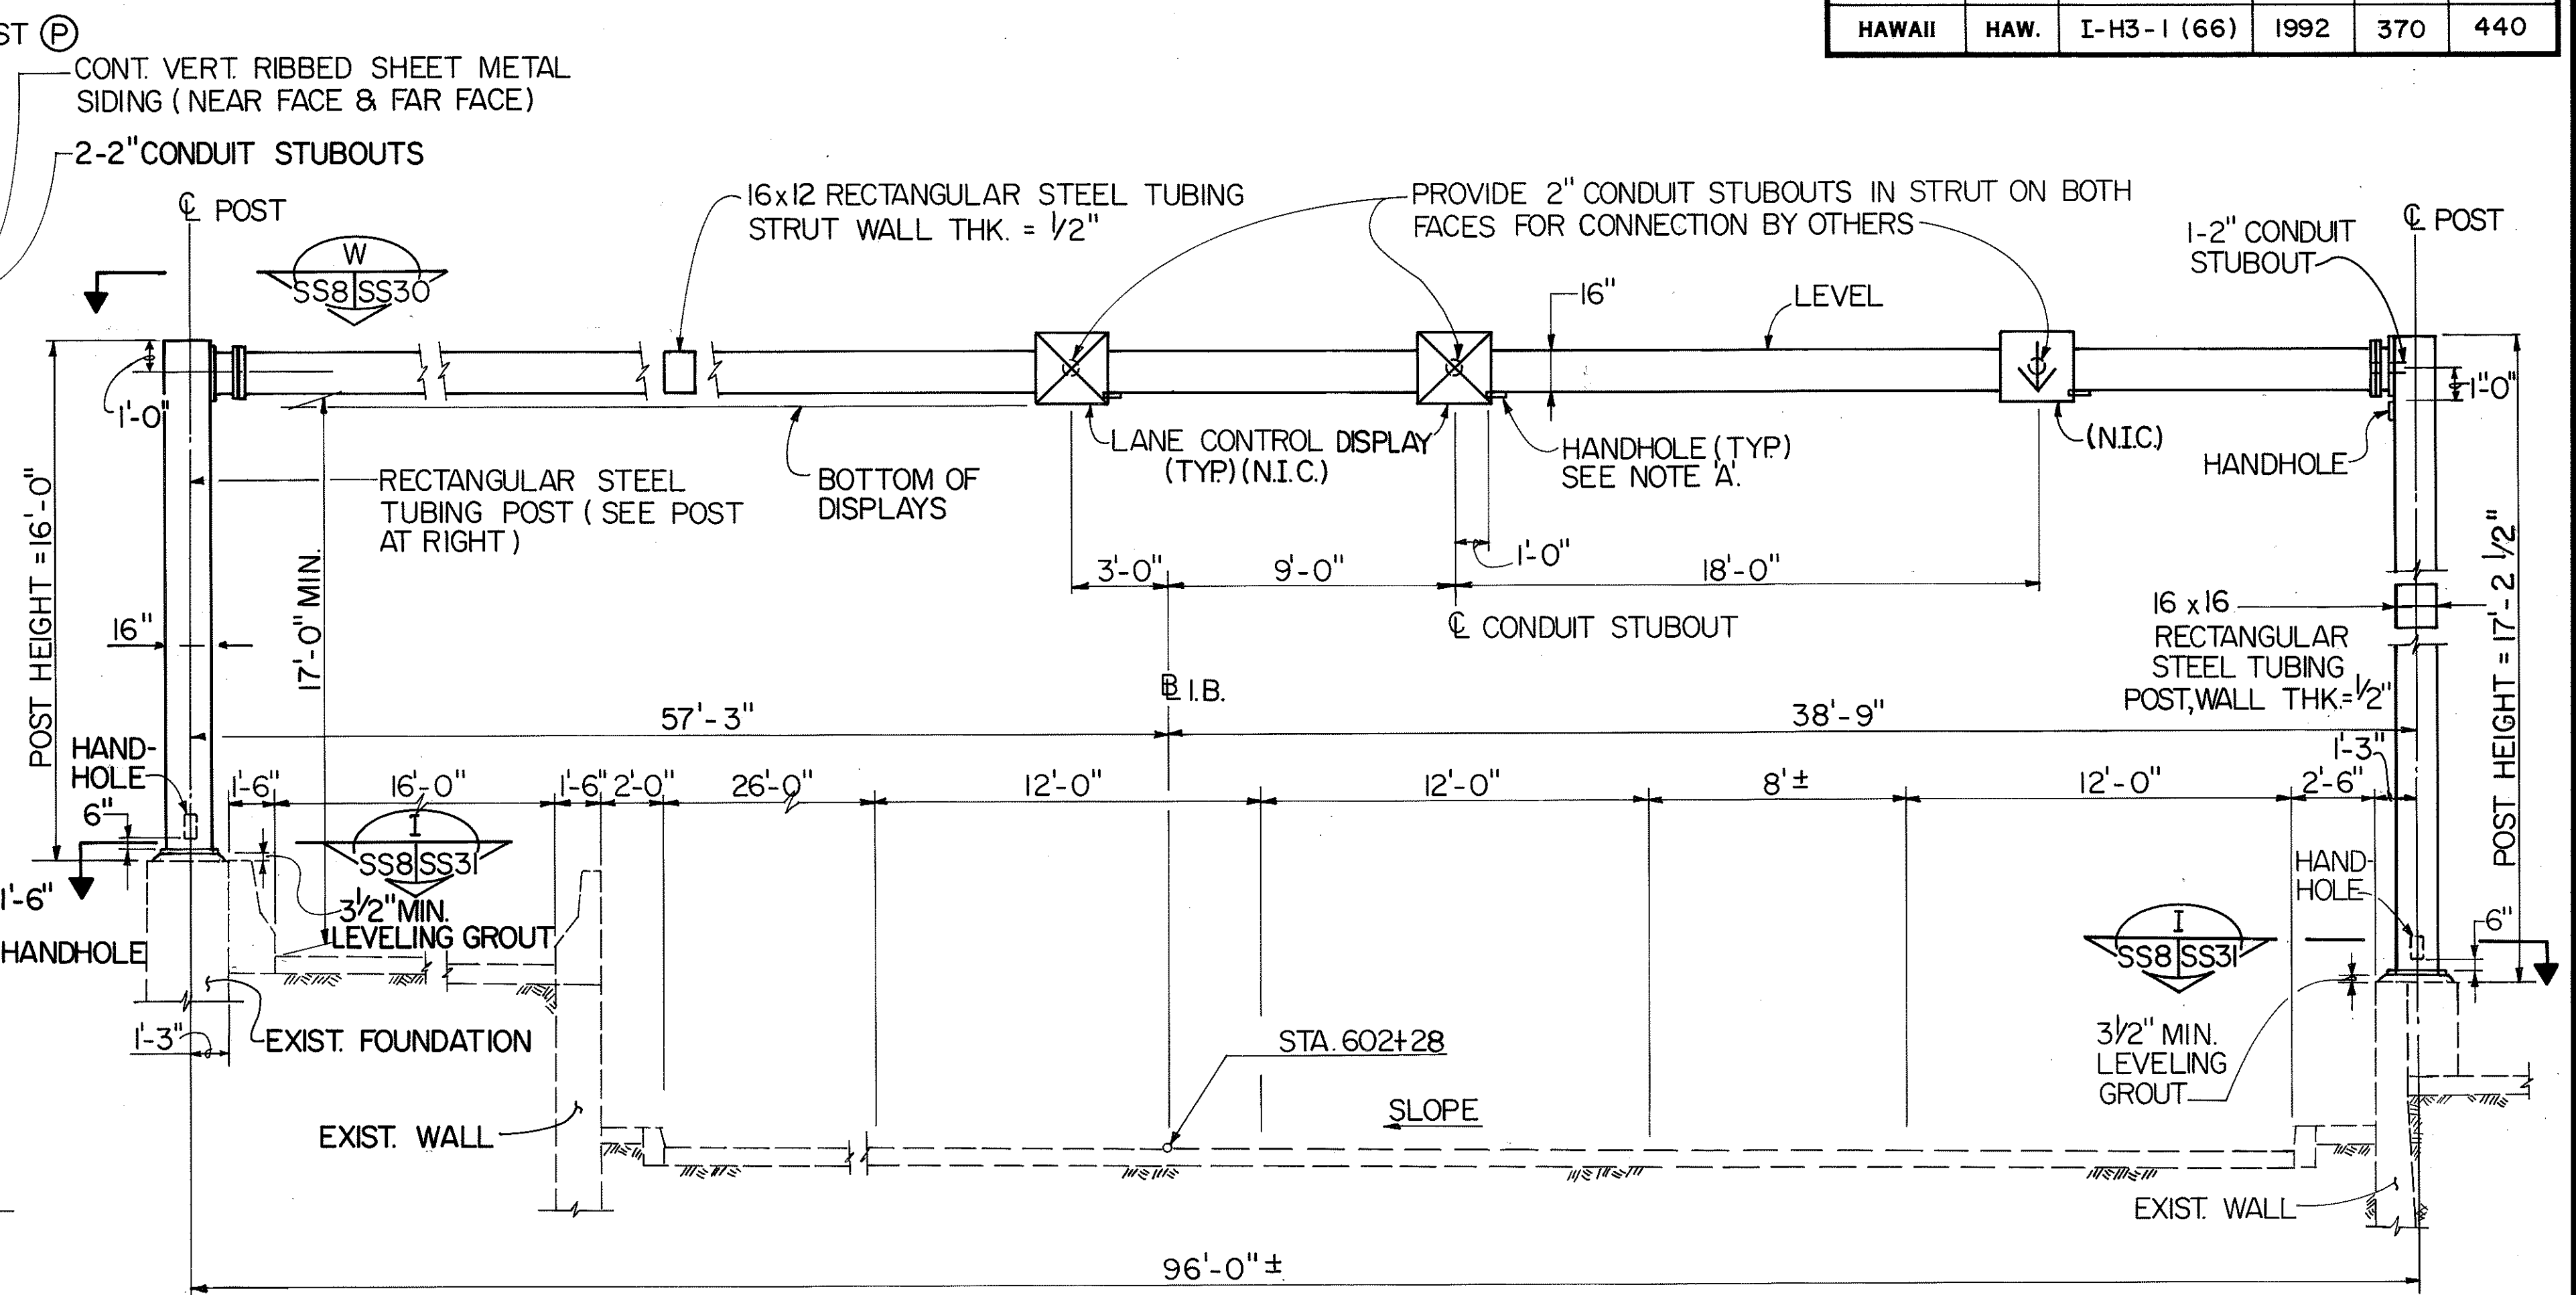


LANE CONTROL DISPLAY SUPPORT AT I.B. STA. 602+28
SCALE: 1/4" = 1'-0"

NOTE 'A' :
PLACE HANDHOLE ON BOTTOM-SIDE OF STRUT
WHERE CONDUIT STUBOUTS ARE PROVIDED. NEAREST
EDGE OF HANDHOLE COVER R IS 1'-0" FROM C CONDUIT
STUBOUT & CENTERED ABOUT C STRUT.

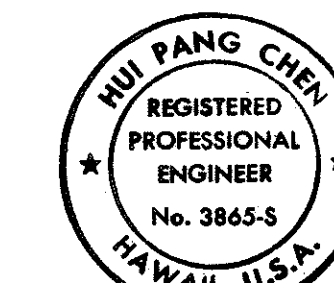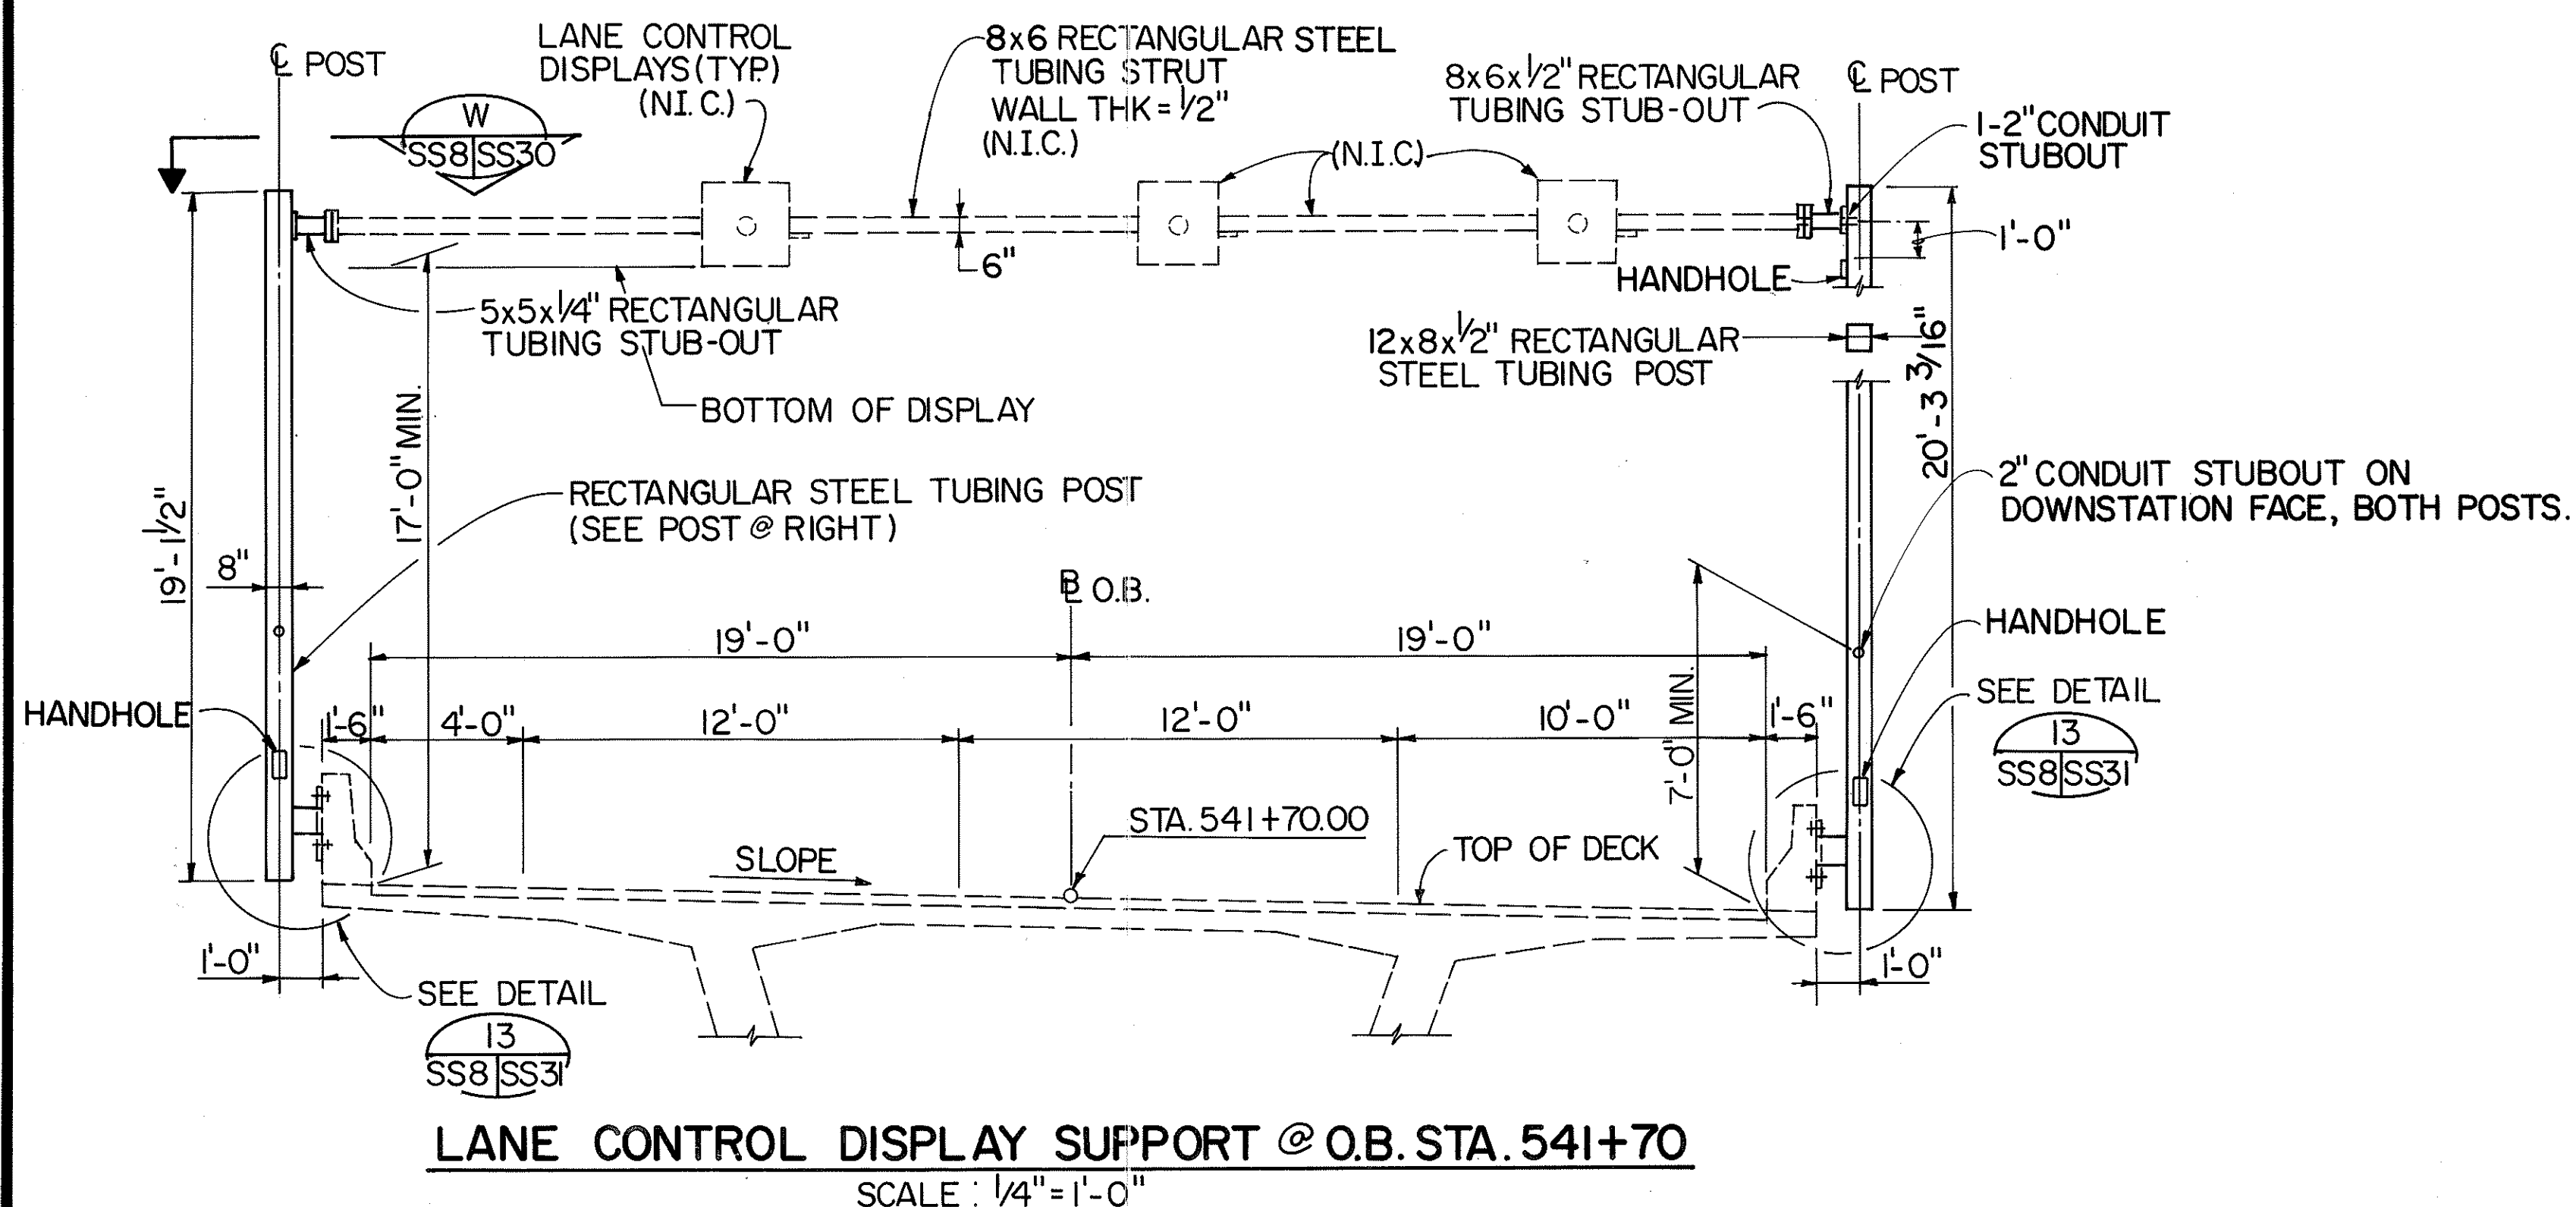

THIS WORK WAS PREPARED BY ME
OR UNDER MY SUPERVISION.

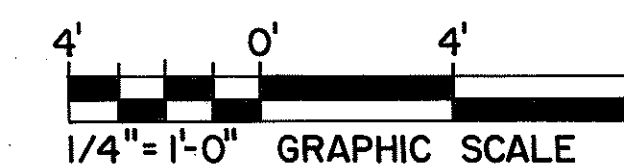

DATE	REVISION

STATE OF HAWAII
DEPARTMENT OF TRANSPORTATION
HIGHWAYS DIVISION


HALAWA APPROACH-
SECTION 3

SUPPORT STRUCTURES
INTERSTATE ROUTE H-3
F.A.I. PROJ. NO. I-H3 - I (66)

SCALE: AS SHOWN DATE : APR. 1992

SHEET No. SS8 OF 36 SHEETS

FED. ROAD DIST. NO.	STATE	FED. AID PROJ. NO.	FISCAL YEAR	SHEET NO.	TOTAL SHEETS
HAWAII	HAW.	I-H3-1(66)	1992	371	440

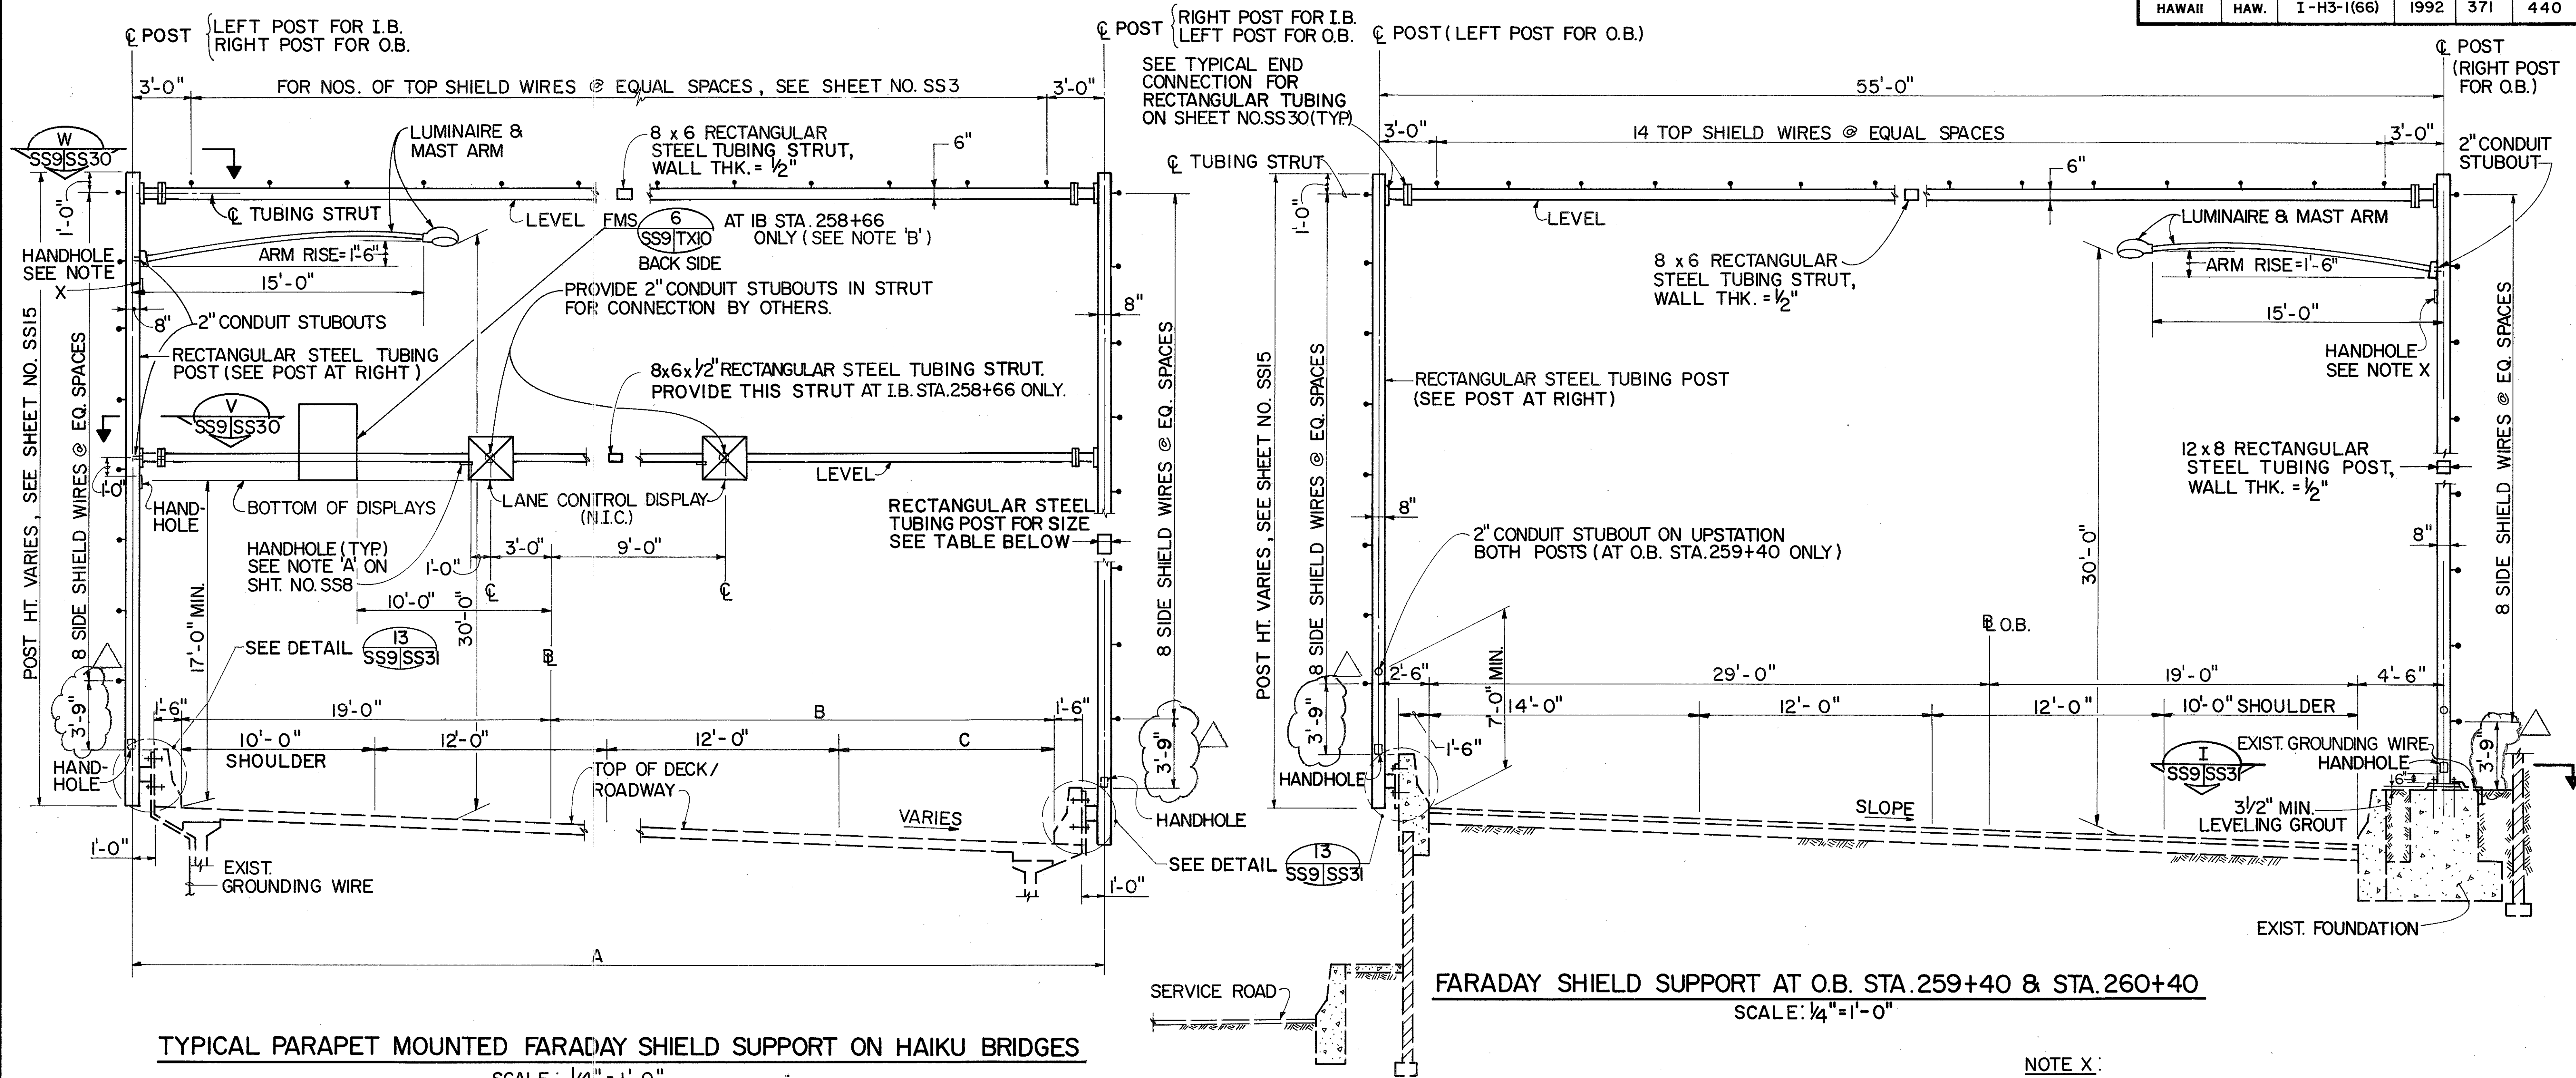


NOTE: TYPICAL I.B. FARADAY SHIELD SUPPORT SHOWN. TYPICAL O.B. FARADAY SHIELD SUPPORT IS OPPOSITE-HAND OF I.B. SUPPORT.

NOTE B: SEE SHEET NO. TXII FOR SIGN MOUNTING DETAILS.

NOTE X:
PLACE HANDHOLE IN SUPPORT POSTS FOR ACCESS WHERE CONDUIT STUBOUT FOR LUMINAIRE WIRING IS PROVIDED. TOP OF HANDHOLE COVER PLATE IS 1'-0" BELOW CONDUIT STUBOUT & CENTERED ABOUT CONDUIT POST.



FARADAY SHIELD SUPPORT LOCATIONS	RECTANGULAR TUBING POST SIZE	A	B	C
I. B. STA. 257+51	16 x 8 x 0.5"	51'	27'	12'
I. B. STA. 258+66	12 x 8 x 0.5"	51'	27'	12'
I. B. STA. 259+70	12 x 8 x 0.5"	51'	27'	12'
I. B. STA. 260+70	12 x 8 x 0.5"	51'	27'	12'
I. B. STA. 261+70	12 x 8 x 0.5"	52'-11 7/8"	28'-11 7/8"	12'
O. B. STA. 258+40	12 x 8 x 0.5"	53'	29'	14'

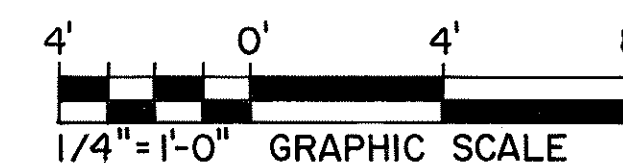



THIS WORK WAS PREPARED BY ME OR UNDER MY SUPERVISION.
Hui Pang Chen

10/26/93	CHANGED 3'-7" DIMENSION TO 3'-9" PER DCN 66-023
DATE	REVISION
STATE OF HAWAII DEPARTMENT OF TRANSPORTATION HIGHWAYS DIVISION	
HAIKU APPROACH - SECTION 1	
SUPPORT STRUCTURES	
INTERSTATE ROUTE H-3	
FAI PROJ. NO. I-H3-1(66)	
SCALE: AS SHOWN	DATE: APR. 1992
SHEET NO. SS9 OF 36 SHEETS	

FED. ROAD DIST. NO.	STATE	FED. AID PROJ. NO.	FISCAL YEAR	SHEET NO.	TOTAL SHEETS
HAWAII	HAW.	I - H3-1(66)	1992	372	440

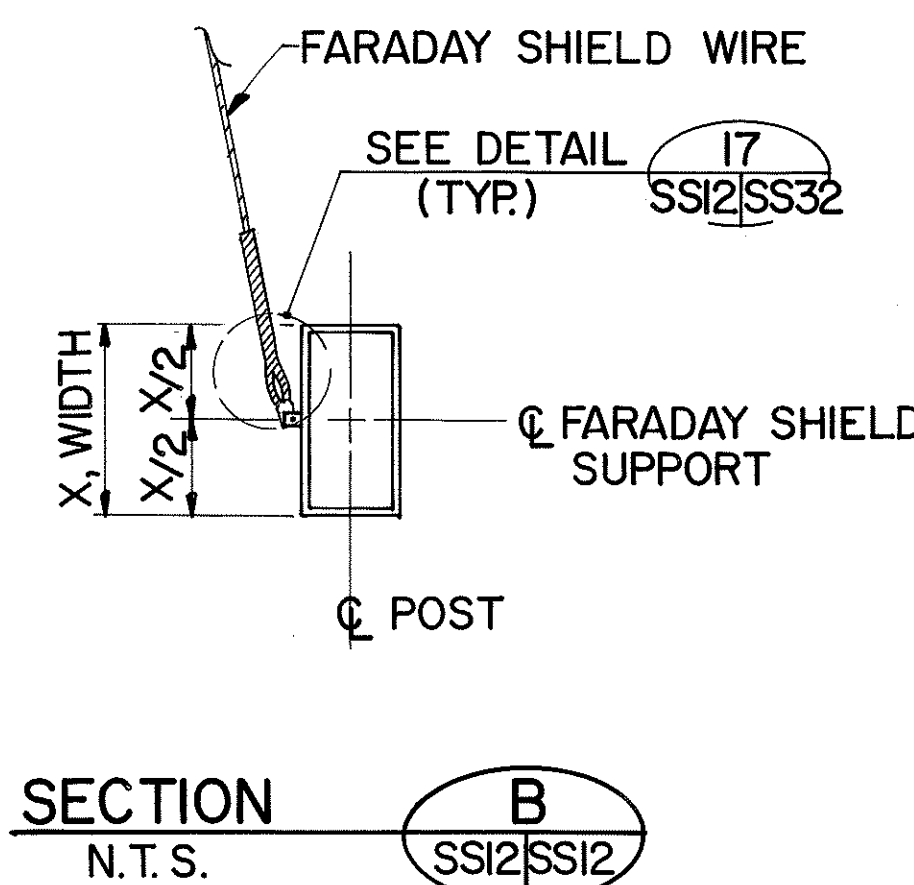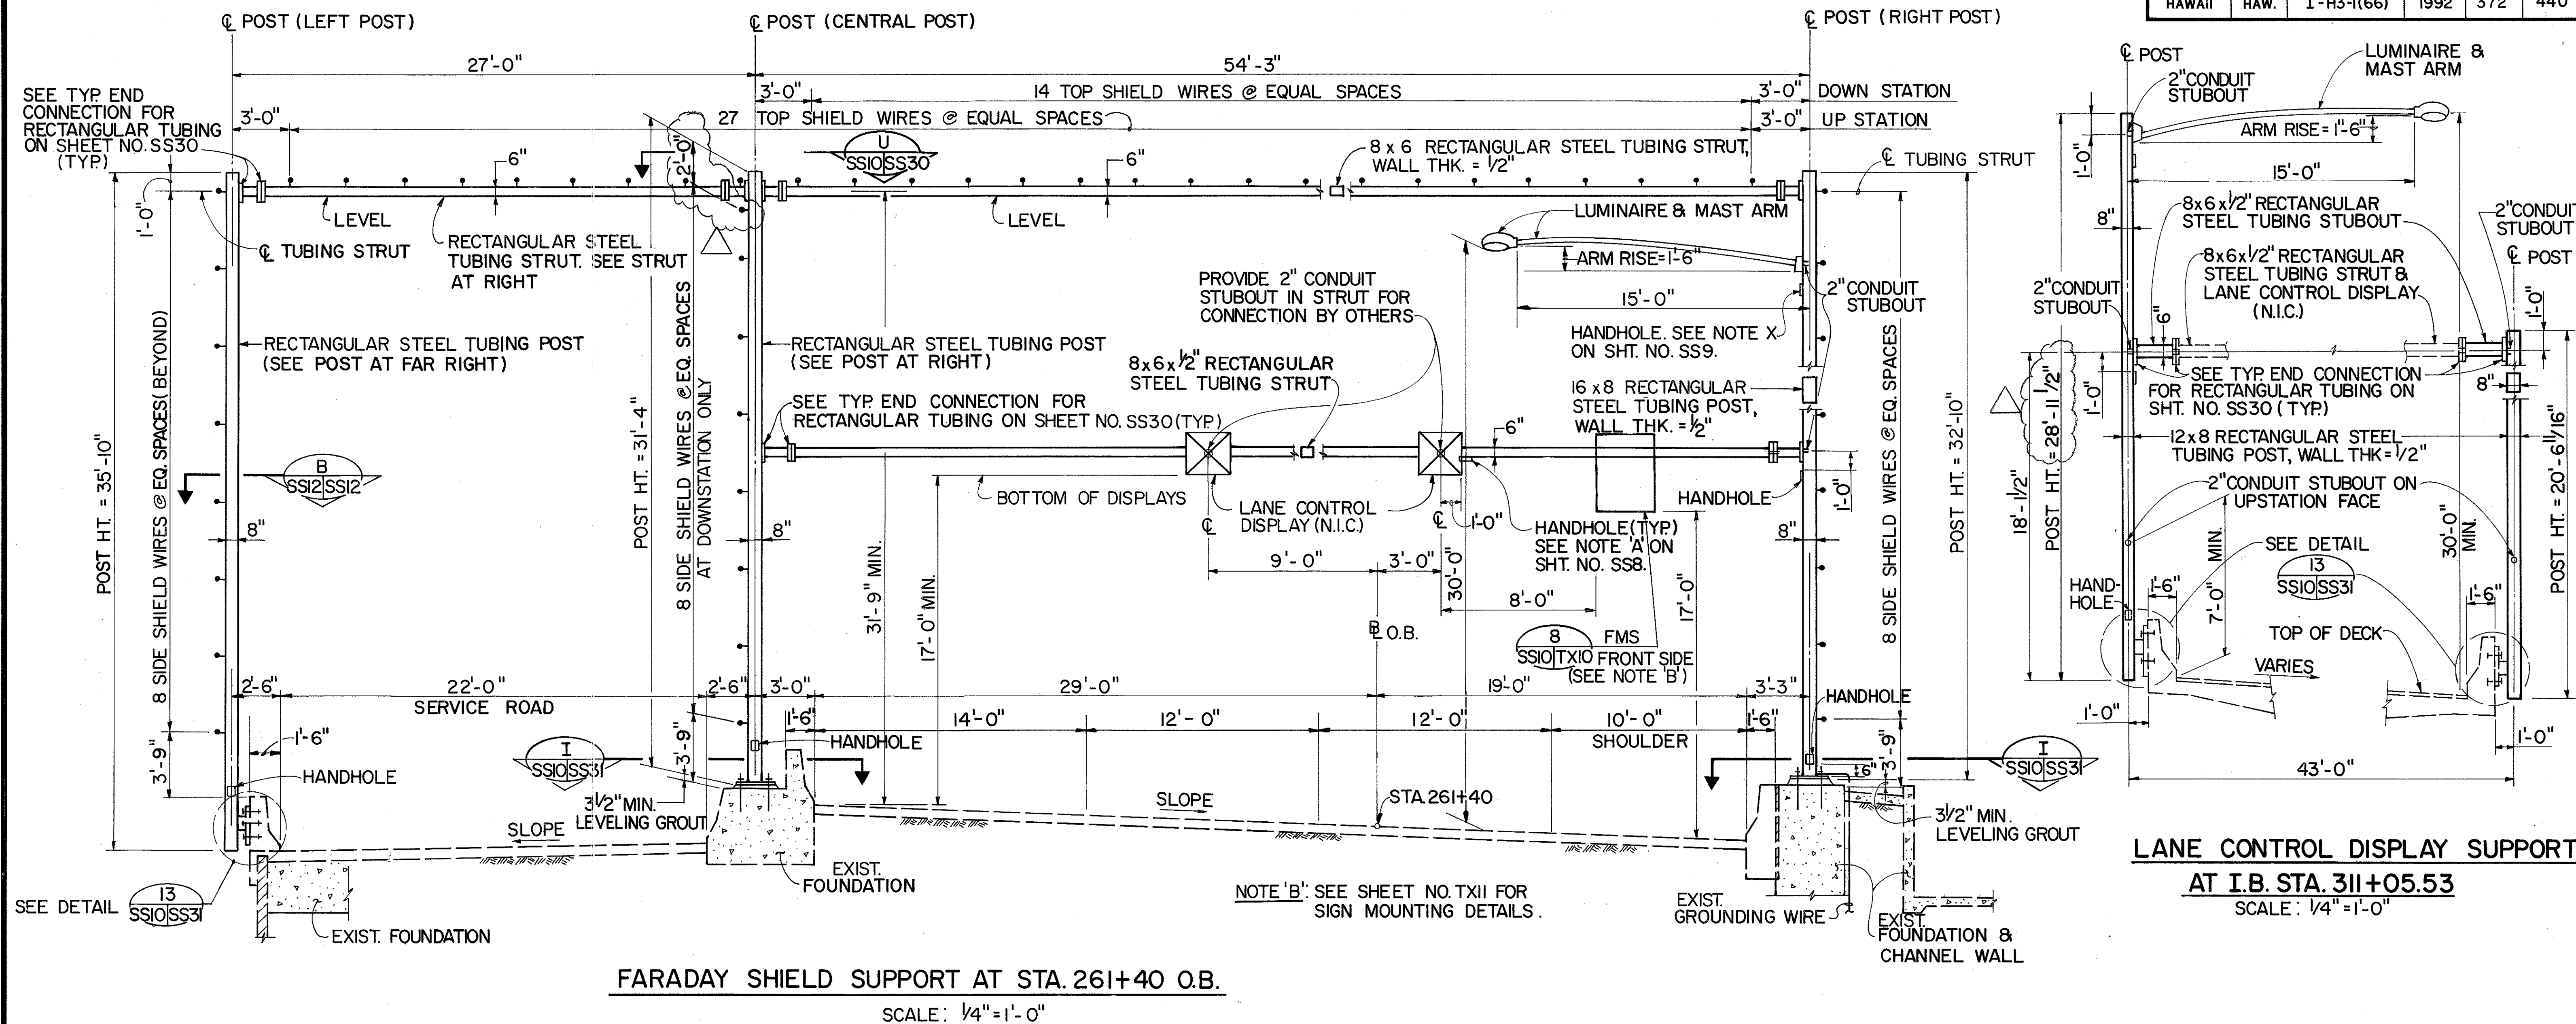


SECTION B
N.T.S.

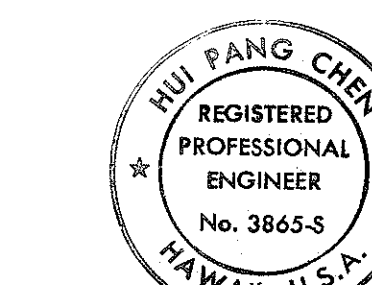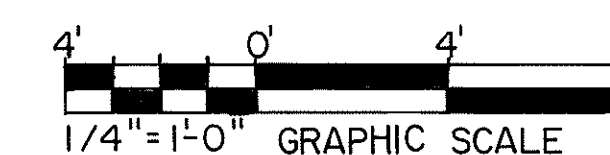

THIS WORK WAS PREPARED BY ME
OR UNDER MY SUPERVISION.
Hui Fang Chen

12/29/93	REV. POST HEIGHT PER DCN 66-027
10/26/93	CHANGED 3'-7" DIMENSION TO 3'-9" PER DCN 66-023
DATE	REVISION
STATE OF HAWAII DEPARTMENT OF TRANSPORTATION HIGHWAYS DIVISION	
HAIKU APPROACH -	
SECTION 2	
SUPPORT STRUCTURES	
INTERSTATE ROUTE H-3	
F.A.I. PROJ. NO. I - H3-1 (66)	
SCALE: AS SHOWN	DATE: APR. 1992
SHEET NO. SS10OF 36 SHEETS	


FED. ROAD DIST. NO.	STATE	FED. AID PROJ. NO.	FISCAL YEAR	SHEET NO.	TOTAL SHEETS
HAWAII	HAW.	I-H3-1(66)	1992	373	440

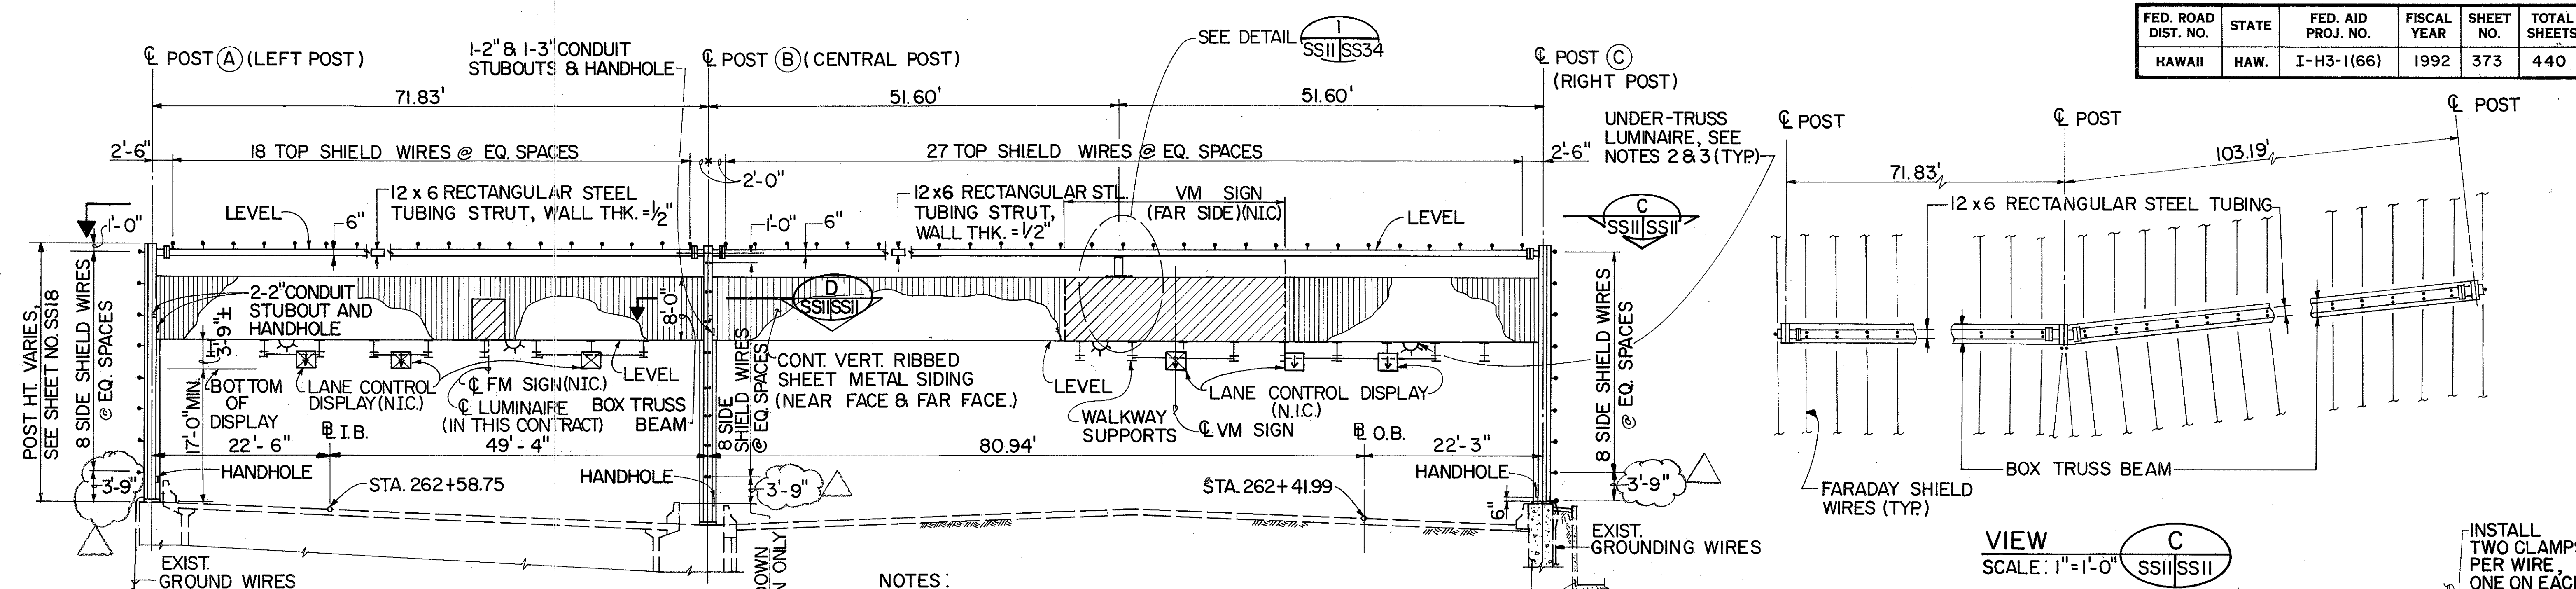


SECTION A
SCALE: 1"=10'-0" SS3|SS11

NOTES:

1. FOR LOCATIONS OF SIGNS, WALKWAY SUPPORTS, LANE CONTROL DISPLAYS AND SIGN LUMINAIRE SEE SHEET NO. SS26.
2. LOCATE UNDER-TRUSS LUMINAIRE (↗) MID-WAY BETWEEN WALKWAY SUPPORTS.
3. FOR UNDER-TRUSS LUMINAIRE (↗) MOUNTING DETAILS SEE SHEET NO. EB19.

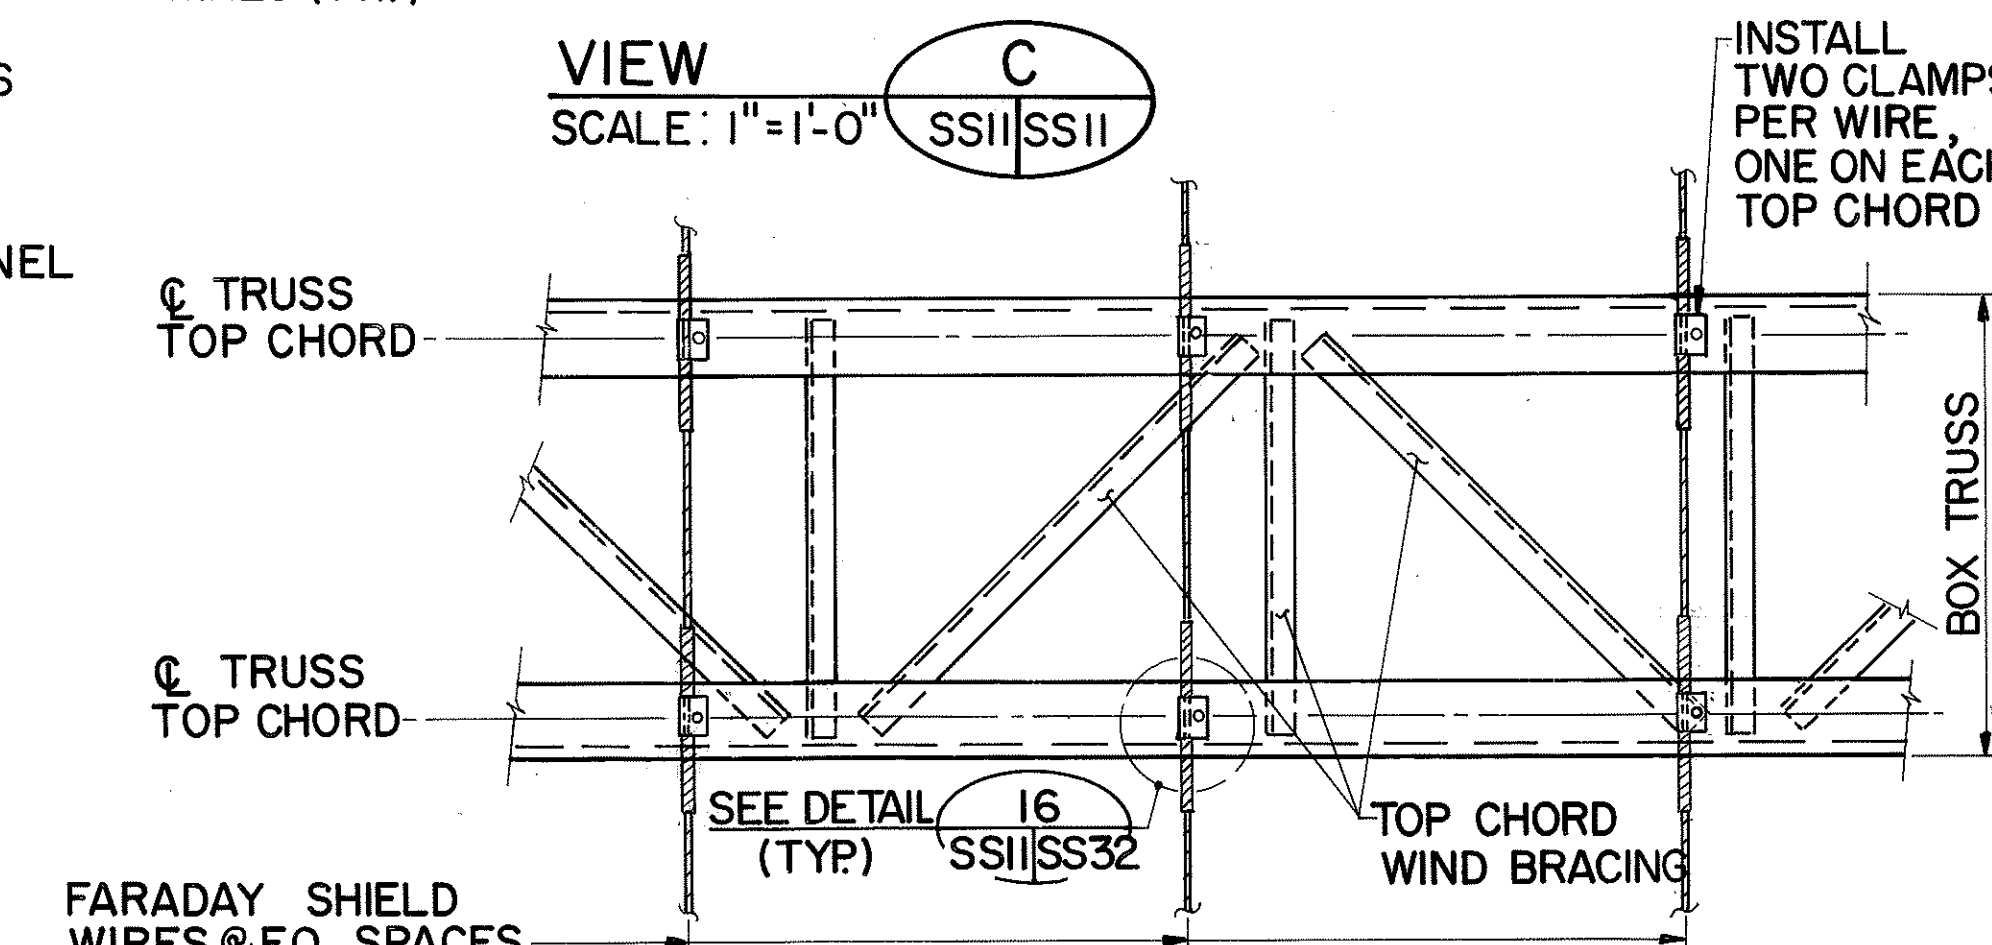


VIEW C
SCALE: 1"=1'-0" SS11|SS11

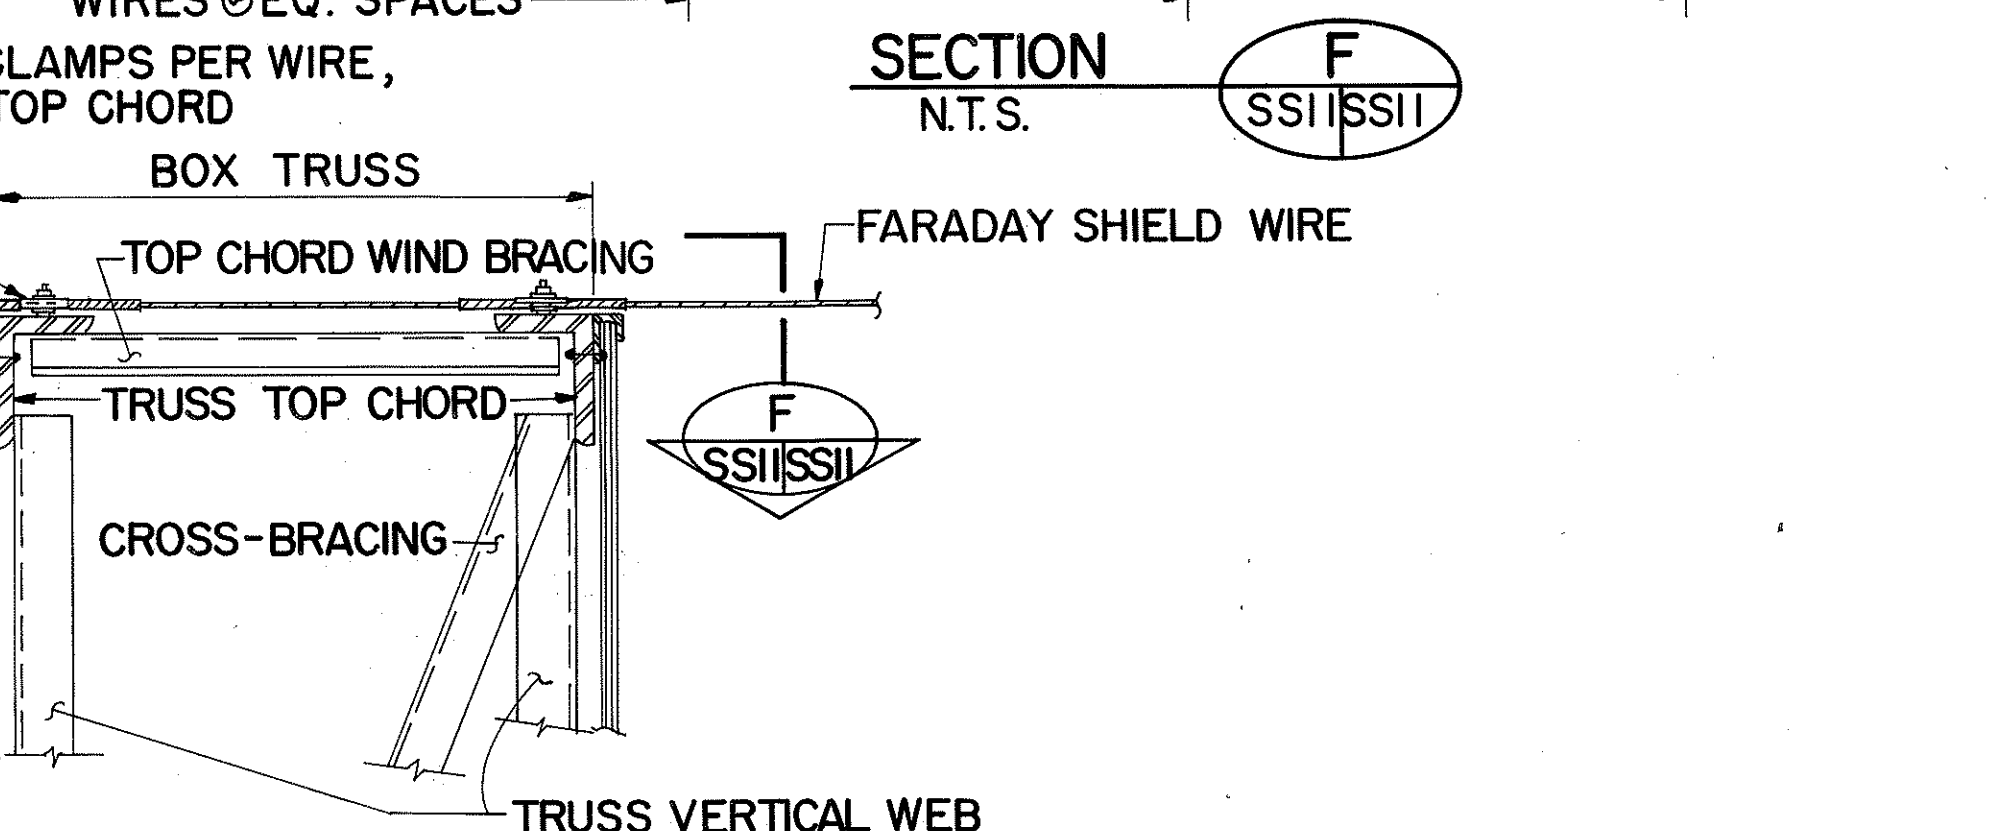


SECTION F
N.T.S. SS11|SS11



SECTION E
N.T.S. SS11|SS11

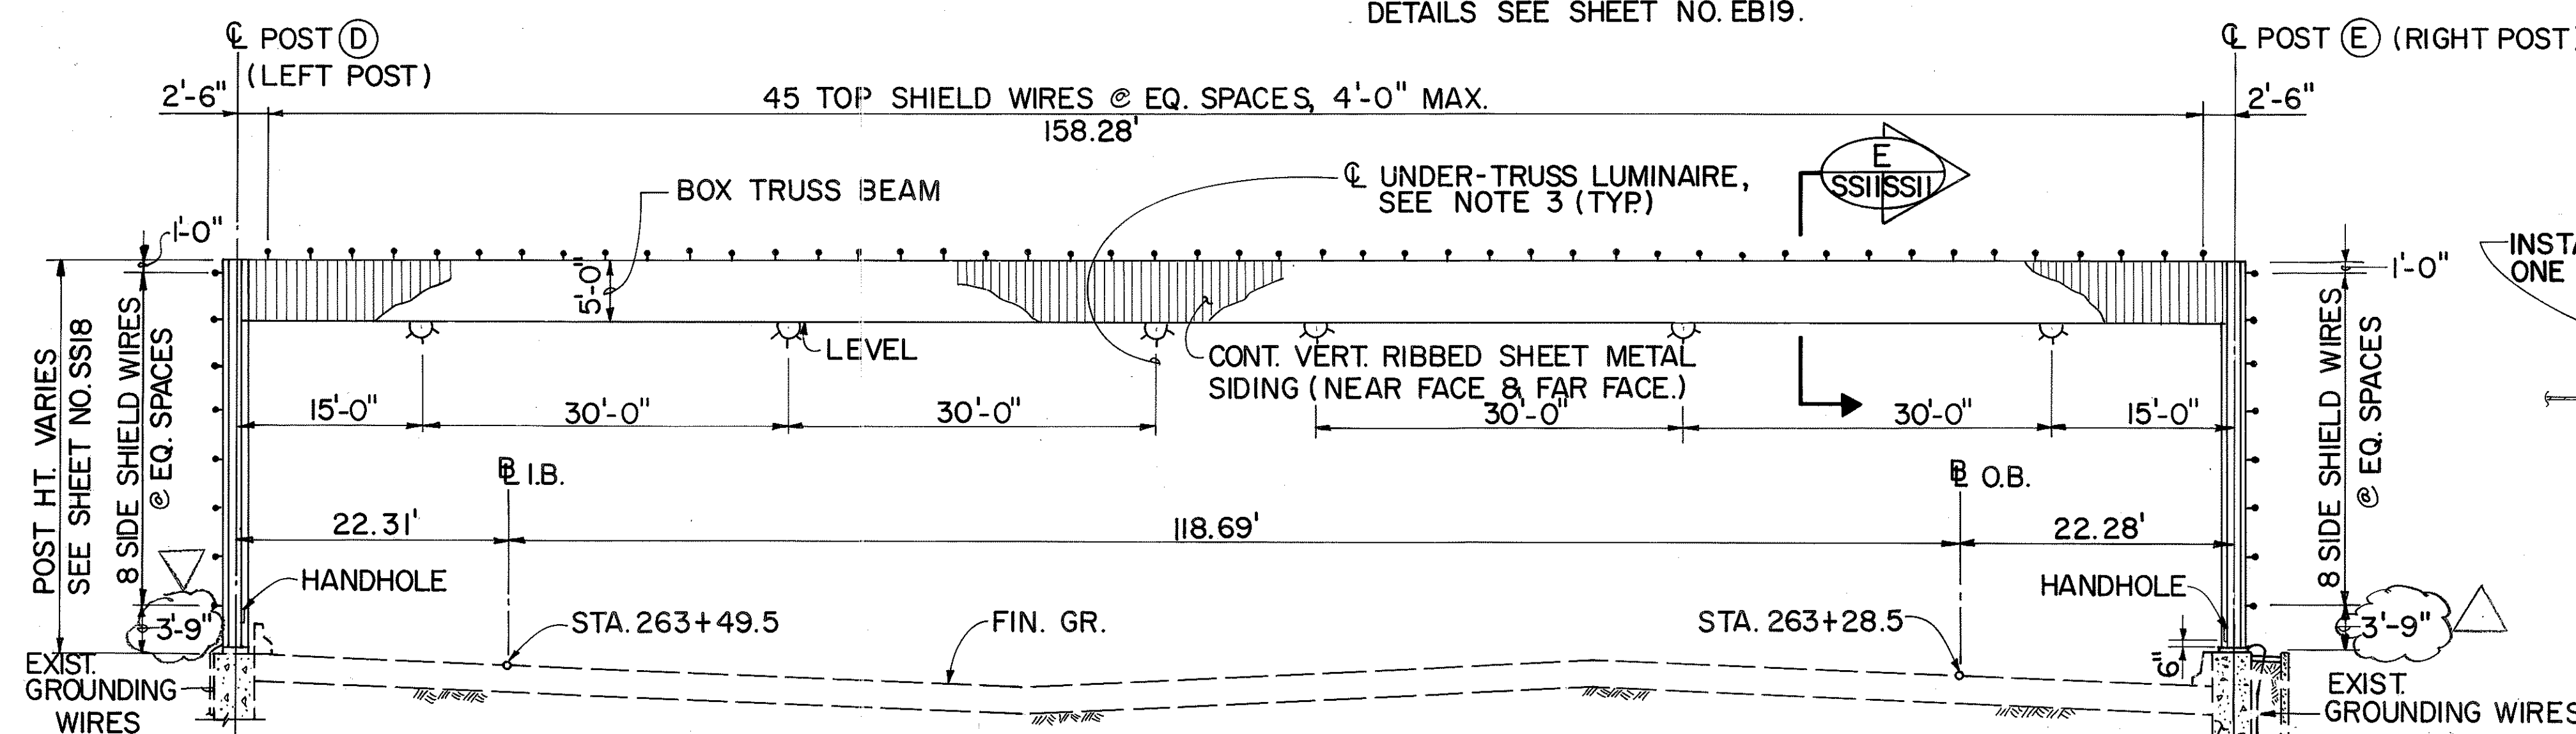

SECTION B
SCALE: 1"=10'-0" SS3|SS11

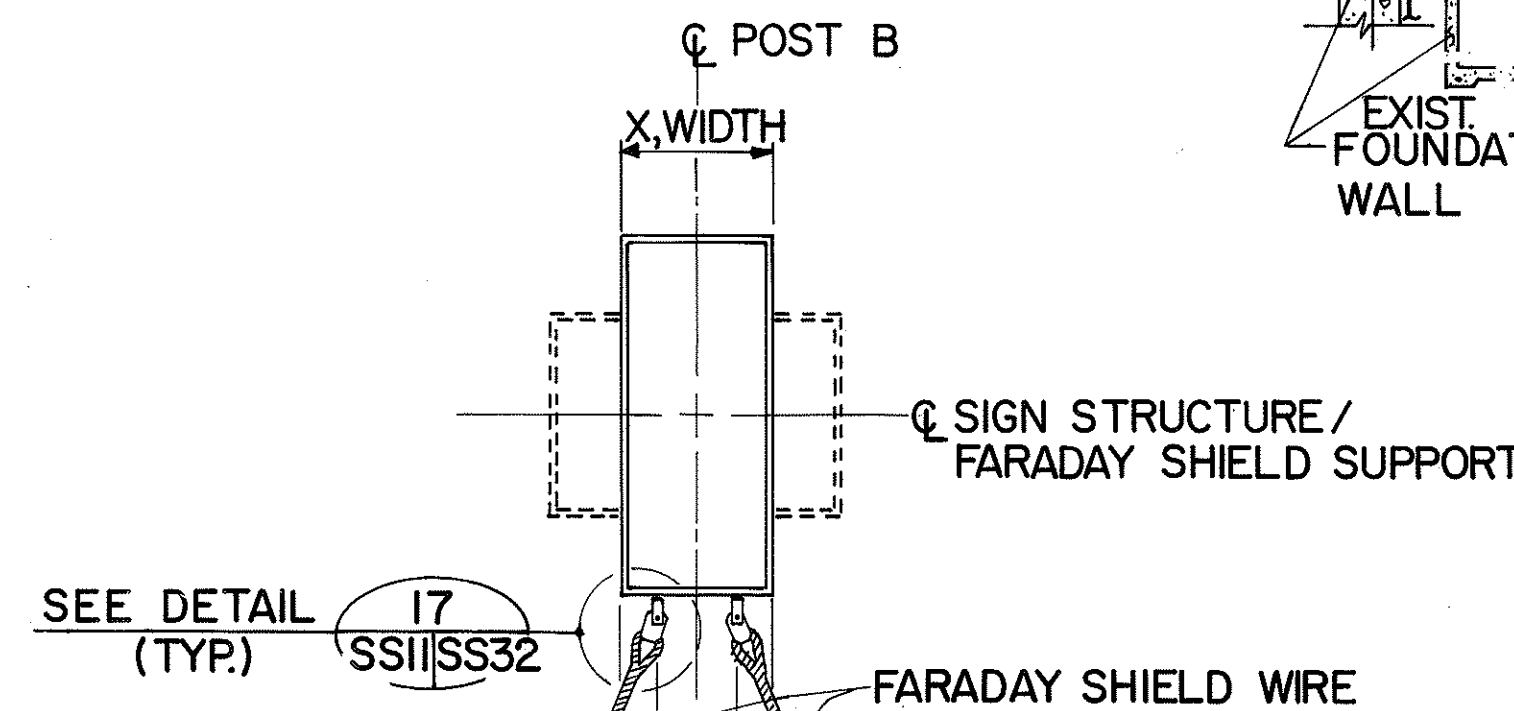


SECTION D
SCALE: 3/4"=1'-0" SS11|SS11

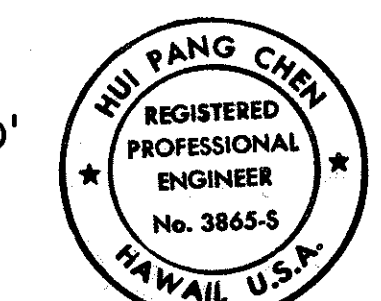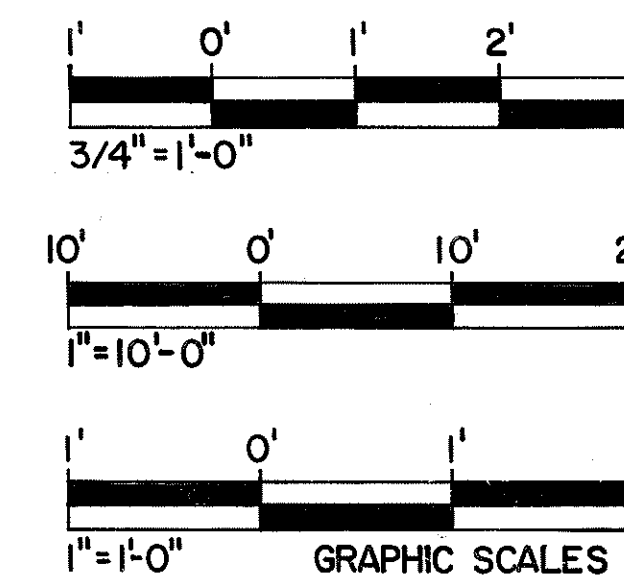

THIS WORK WAS PREPARED BY ME OR UNDER MY SUPERVISION.
Hui Pang Chen

10/26/93	CHANGED 3'-7" DIMENSION TO 3'-9" PER DCN 66-023
5-25-93	REVISED SECTIONS E & F PER DCN 66-008
DATE	REVISION
STATE OF HAWAII DEPARTMENT OF TRANSPORTATION HIGHWAYS DIVISION	
HAIKU APPROACH -	
SECTION 3	
SUPPORT STRUCTURES	
INTERSTATE ROUTE H-3	
F.A.I. PROJ. NO. I-H3-(66)	
SCALE: AS SHOWN	DATE: APR. 1992
SHEET NO. SS11 OF 36 SHEETS	

FED. ROAD DIST. NO.	STATE	FED. AID PROJ. NO.	FISCAL YEAR	SHEET NO.	TOTAL SHEETS
HAWAII	HAW.	I-H3-1(66)	1992	374	440

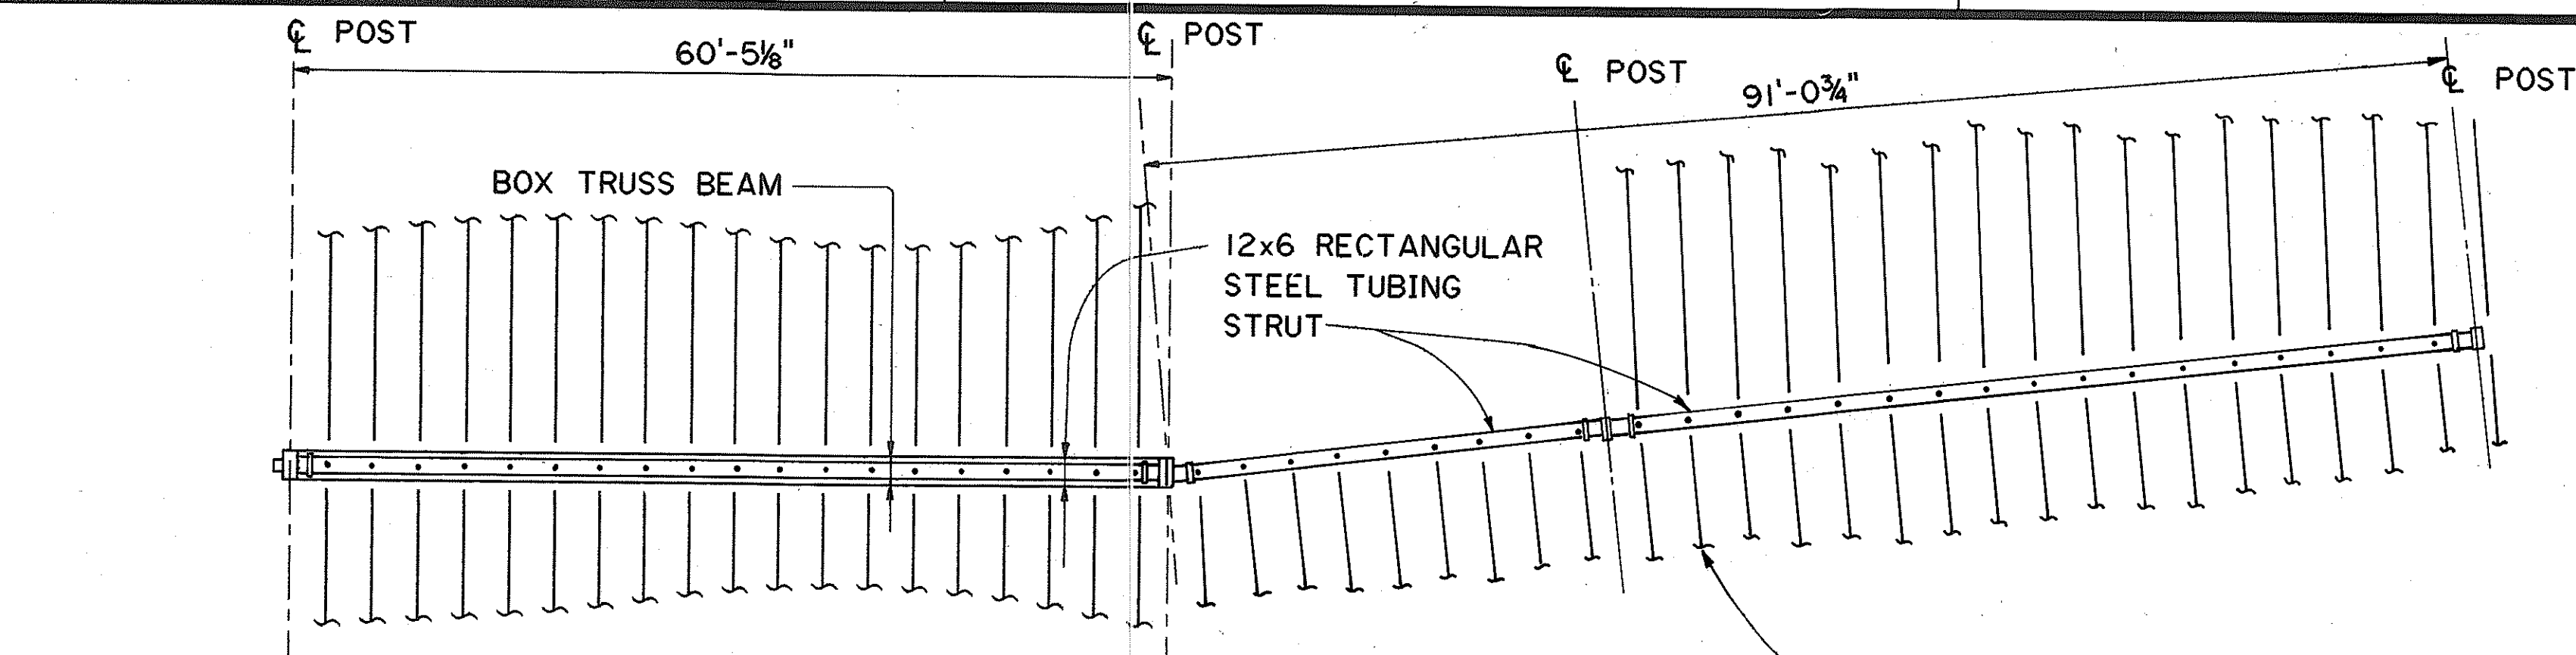


VIEW

SCALE: 1" = 10'-0"

A
SS12 SS12


FARADAY SHIELD WIRES (TYP.)

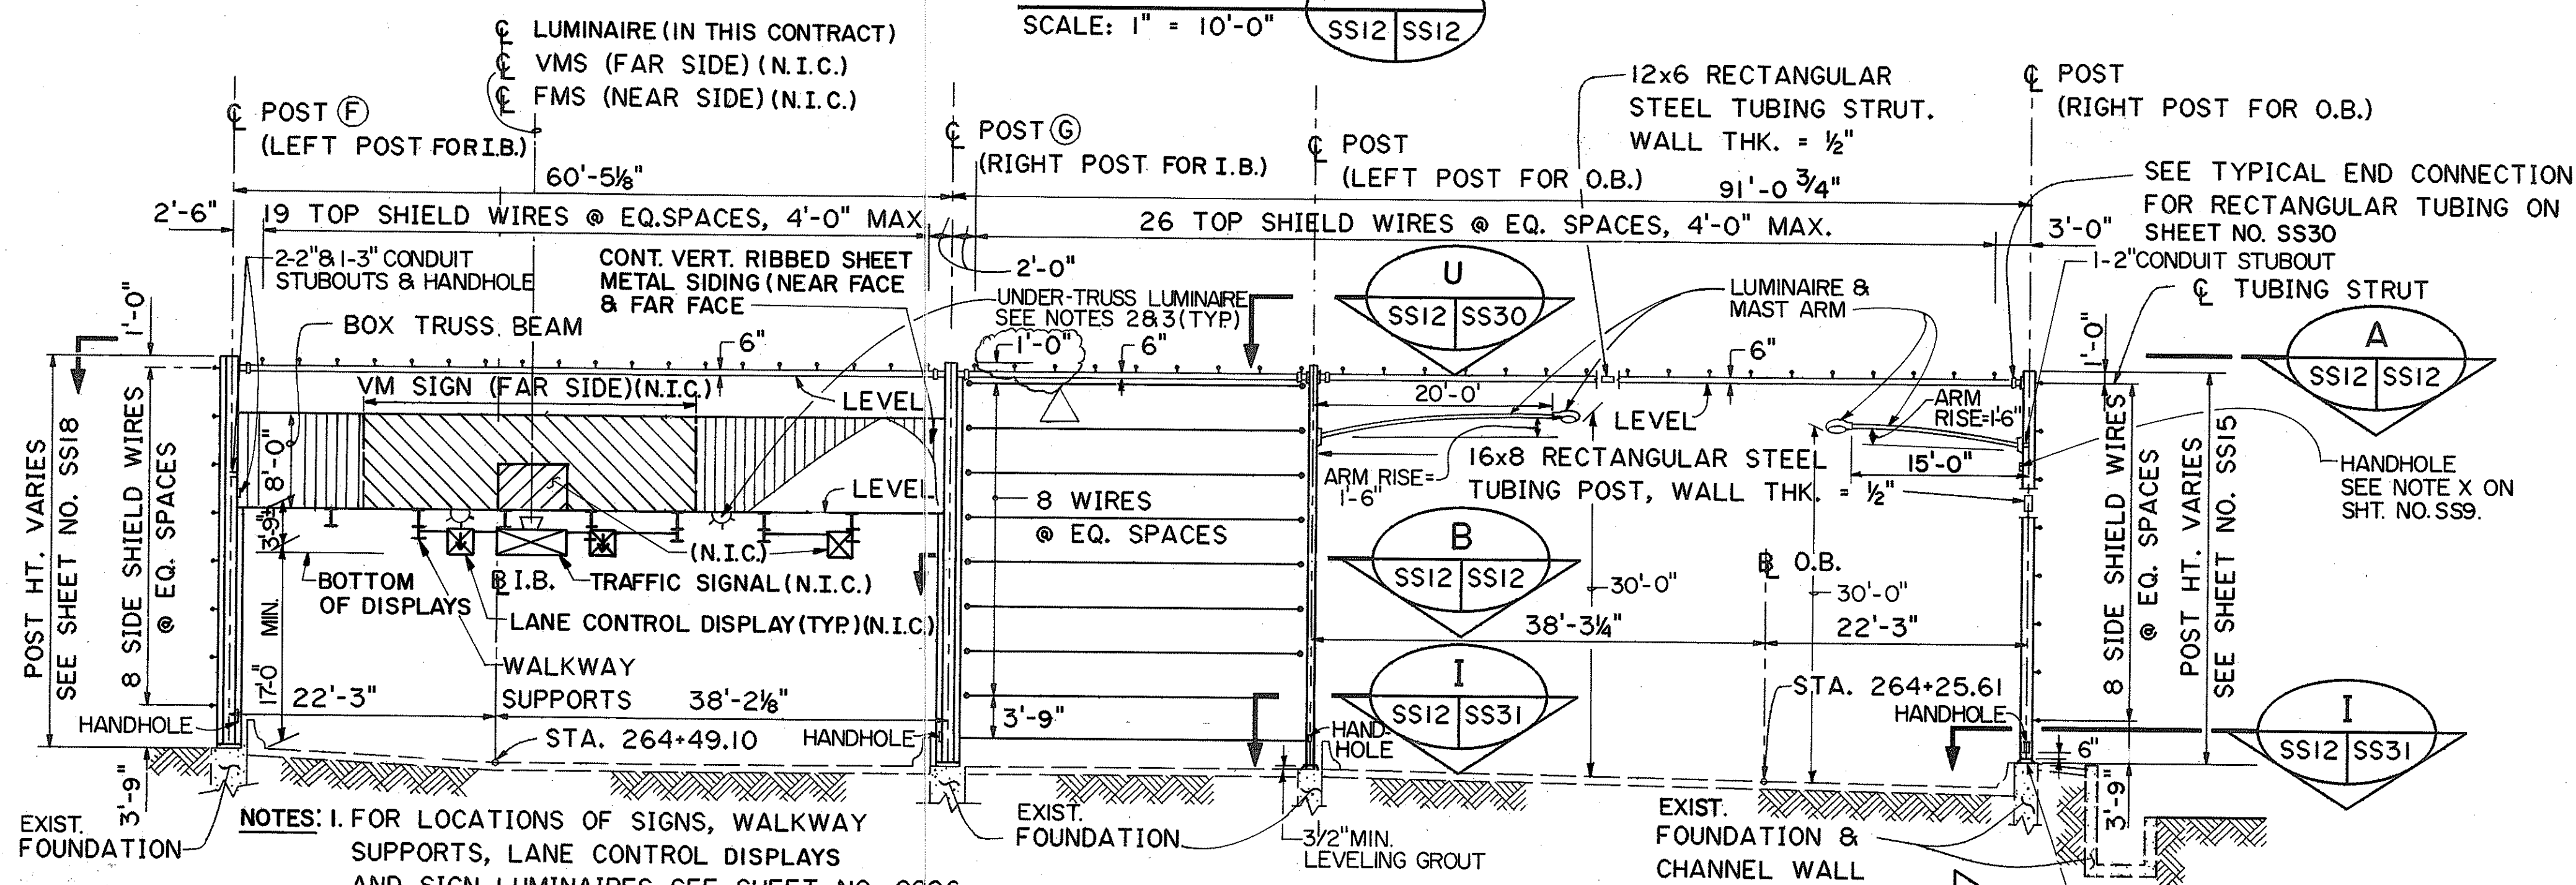

SECTION

SCALE: 1" = 10'-0"


C
SS3 SS12

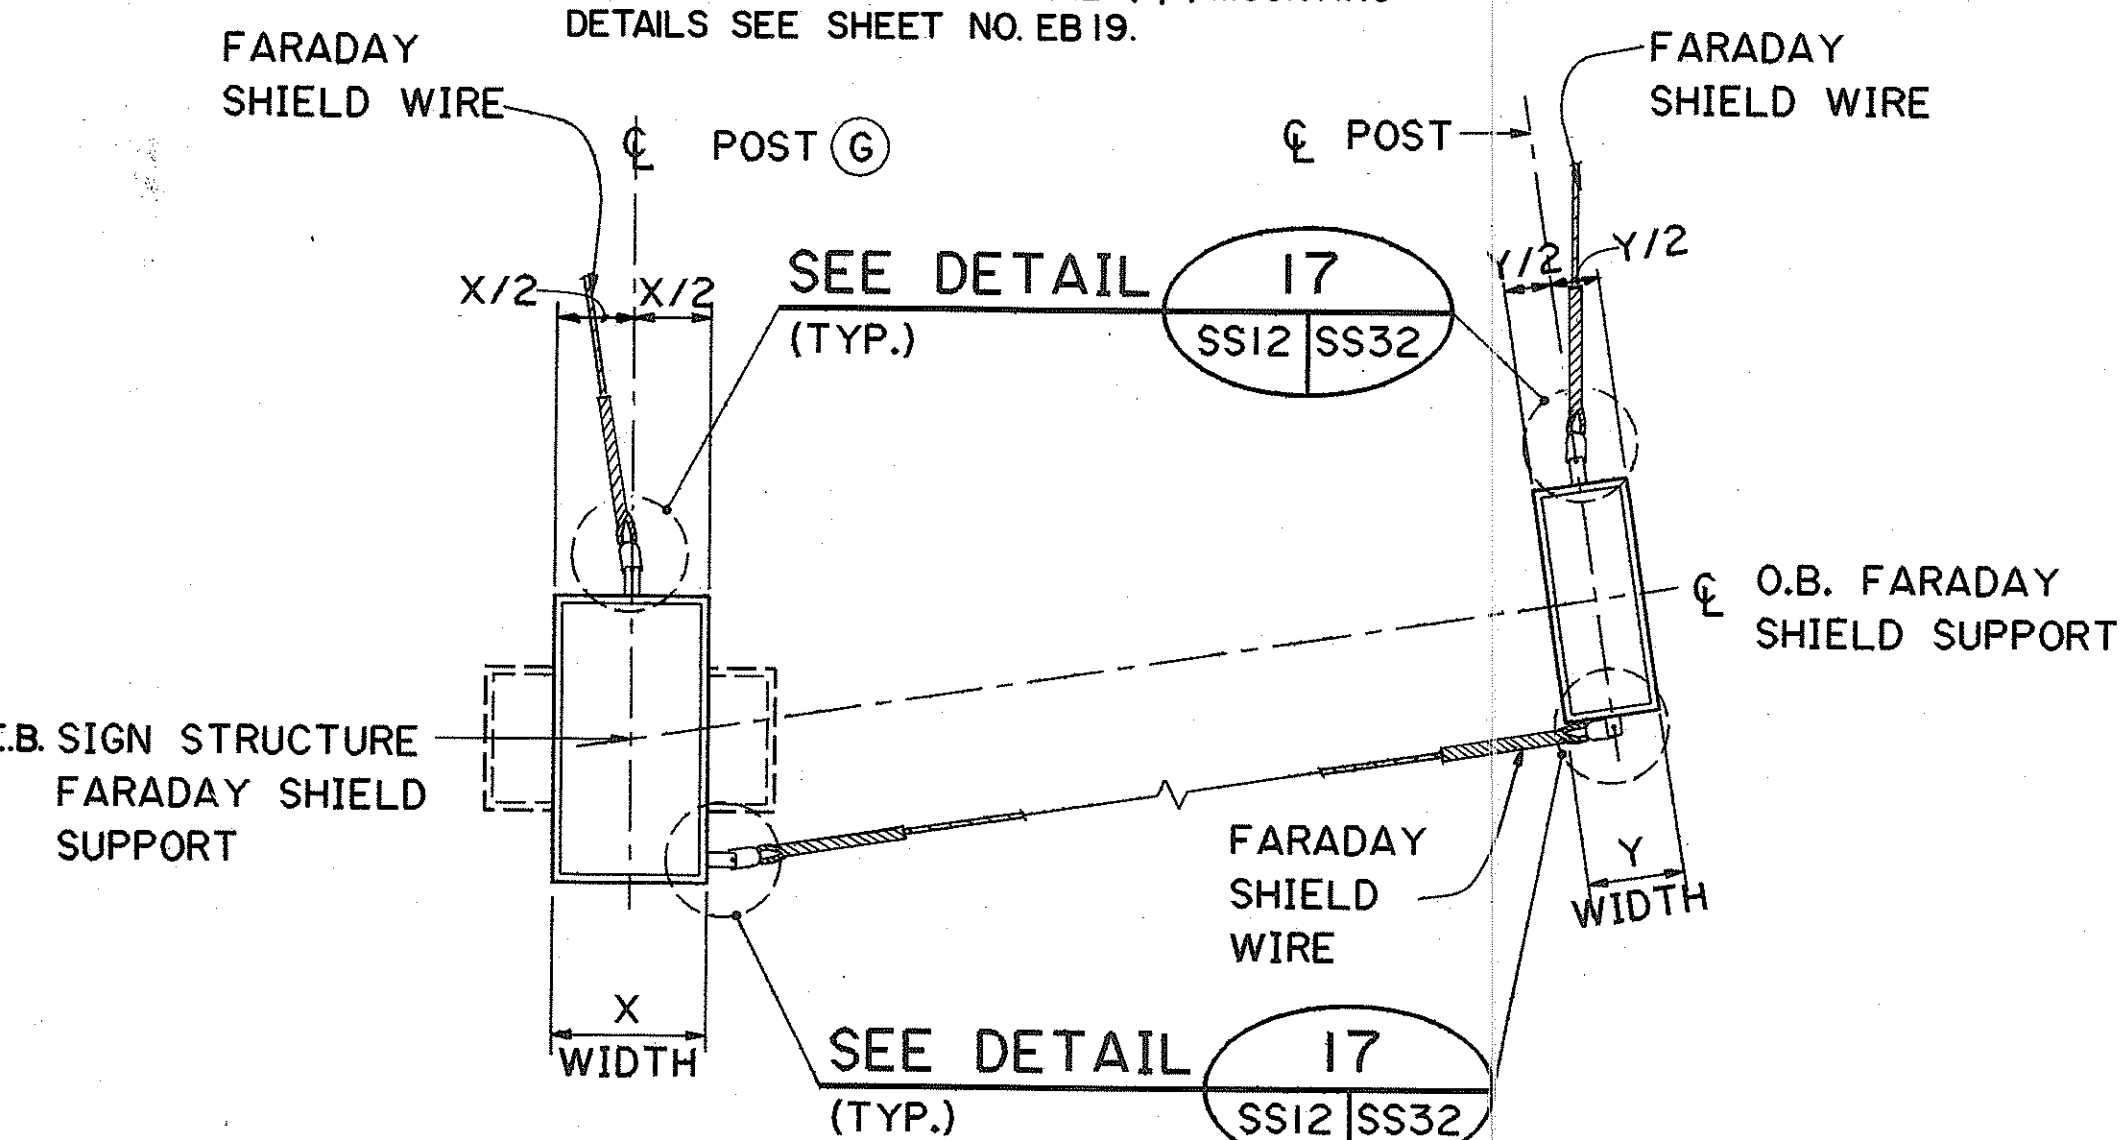

SECTION

N.T.S.


B
SS12 SS12

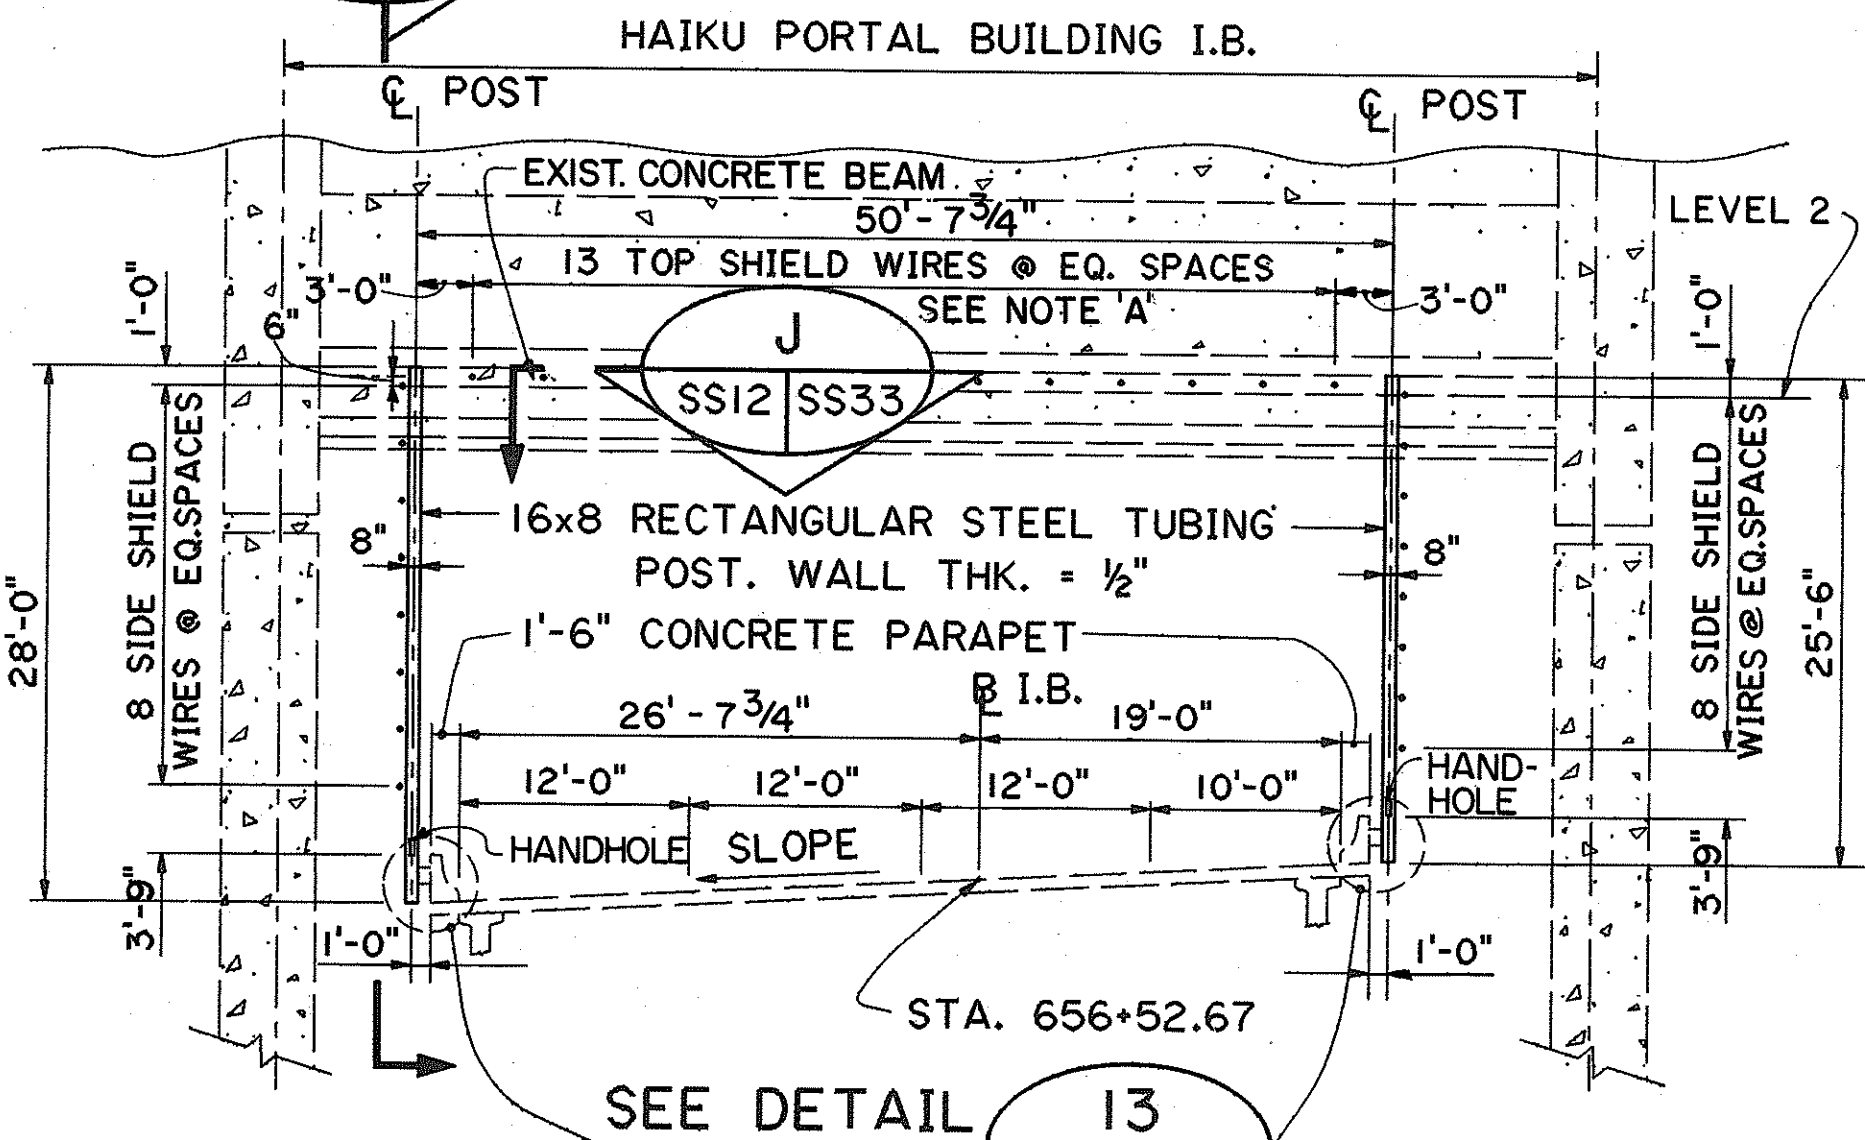

SECTION

SCALE: 1" = 10'-0"

E
SS3 SS12

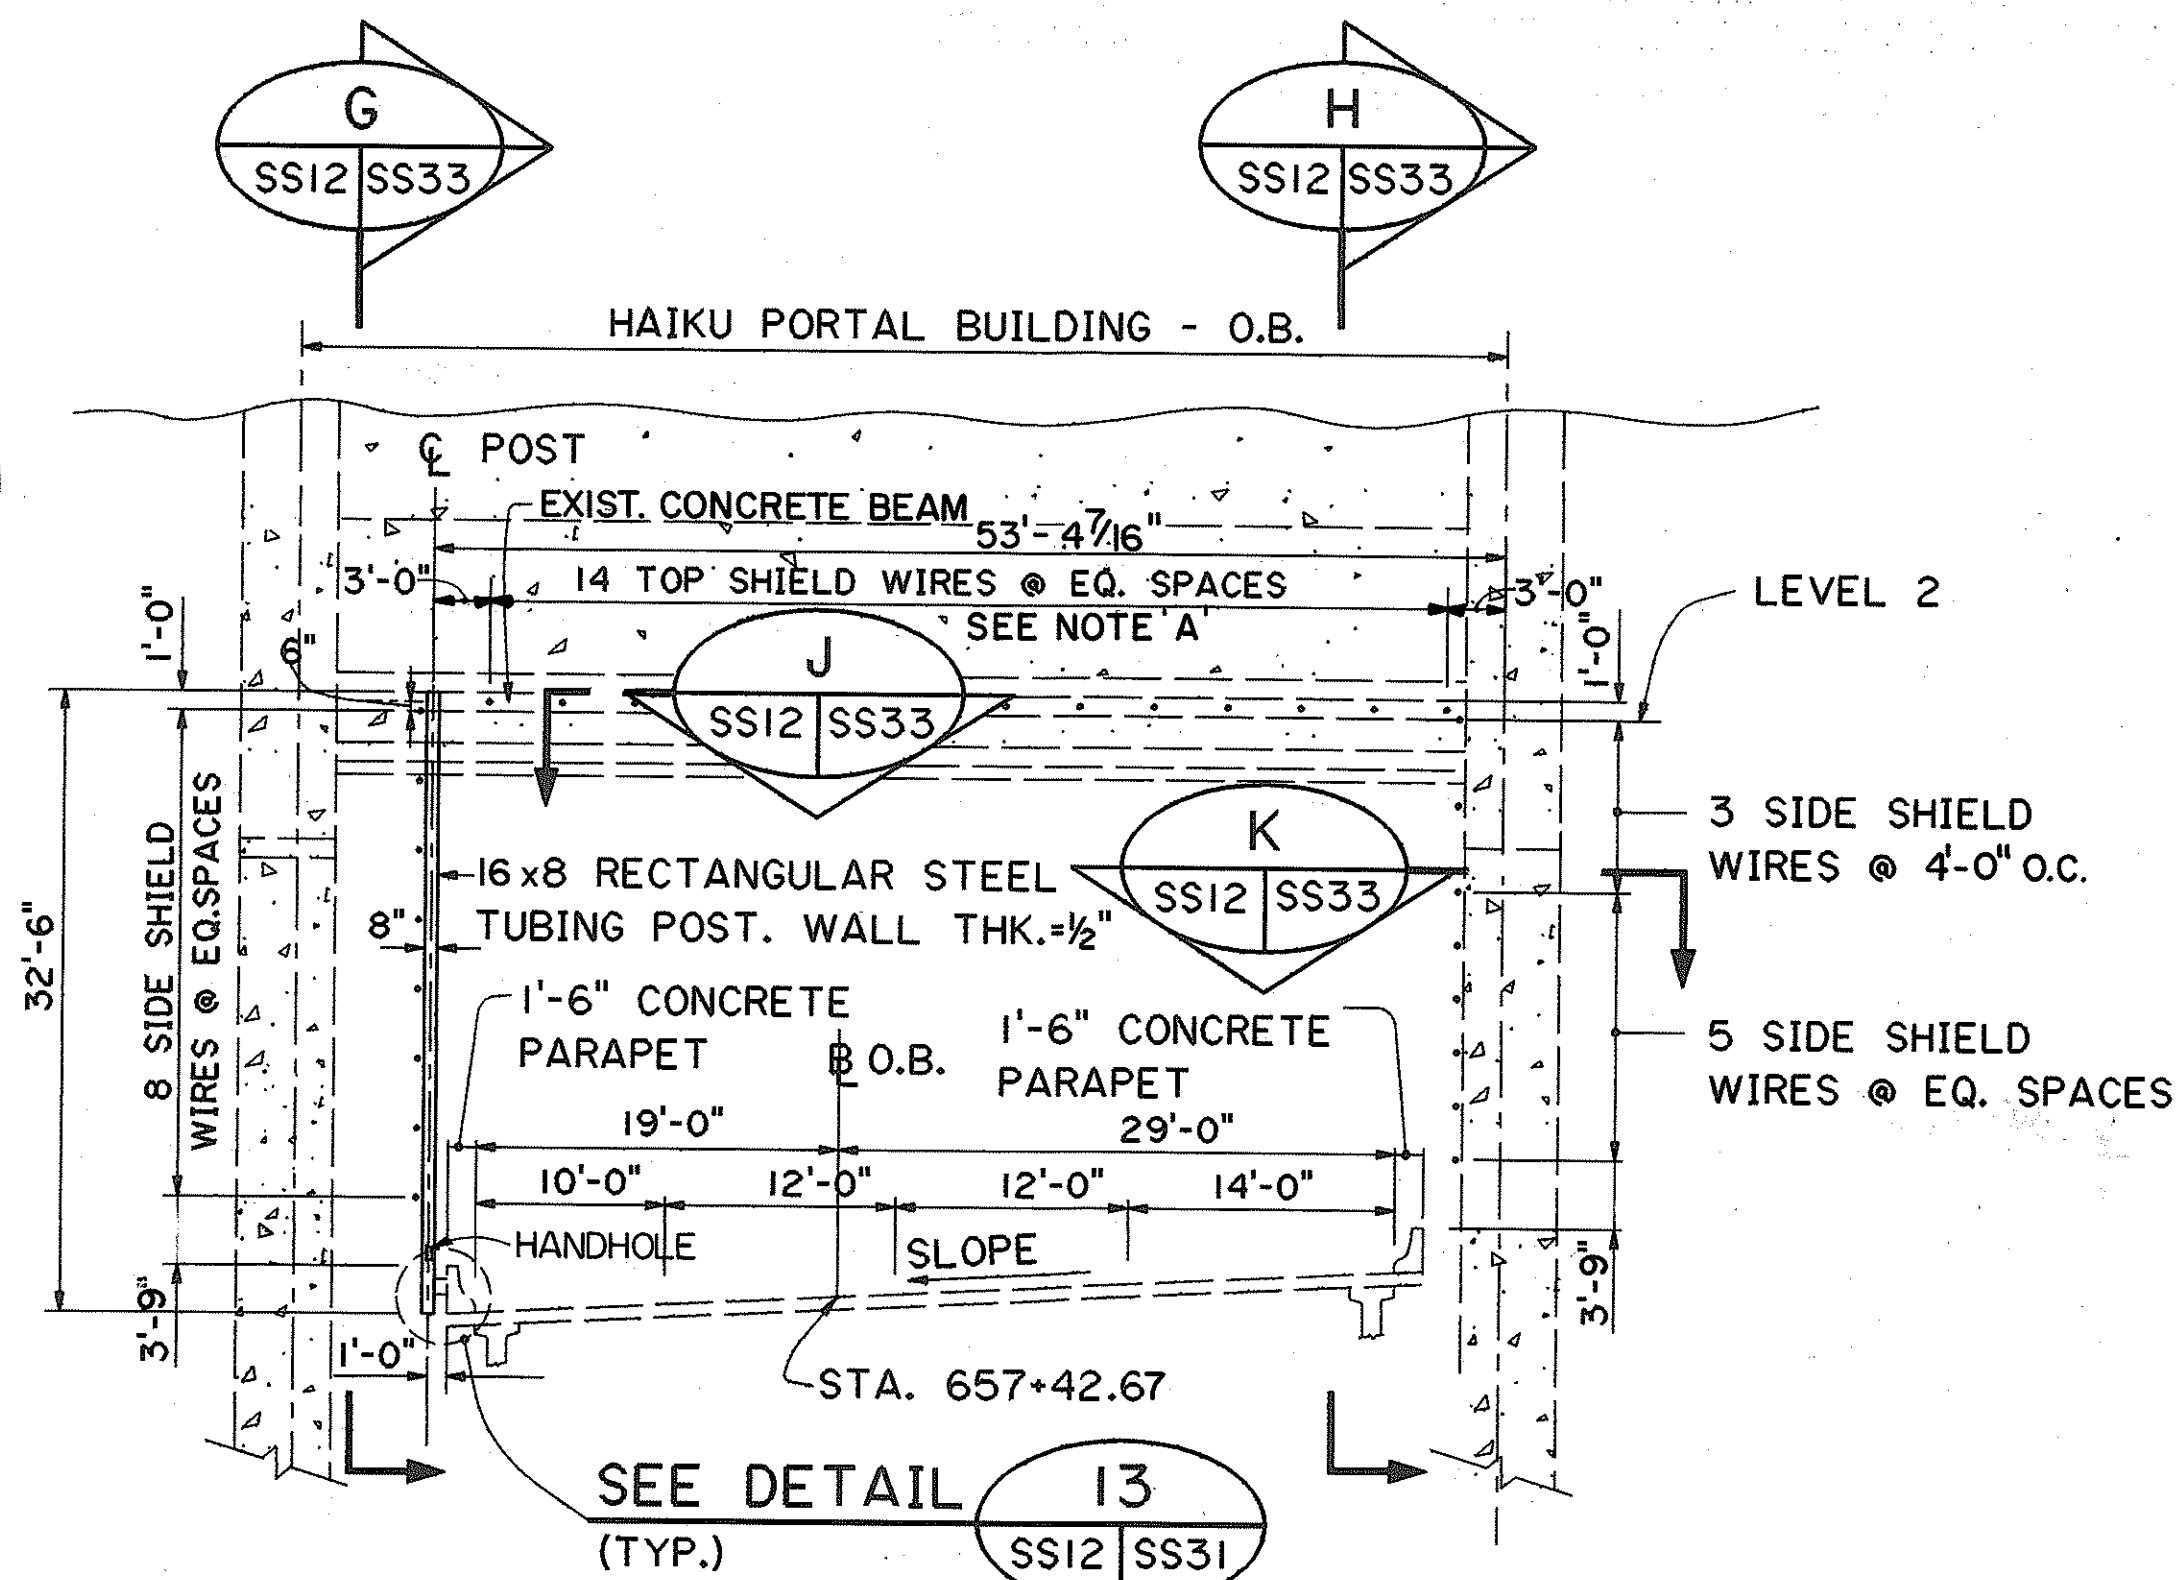


SECTION

SCALE: 1" = 10'-0"

F
SS3 SS12


NOTE:
A. PRIOR TO INSTALLATION OF SHIELD WIRES, CONTRACTOR SHALL VERIFY THE TOP SHIELD WIRE SPACINGS WITH THE EXISTING CONCRETE INSERTS IN PORTAL BUILDING BEAM. THE CONTRACTOR SHALL ALSO SUBMIT THE SURVEYED LOCATIONS OF THE INSERTS TO THE ENGINEER FOR REVIEW.

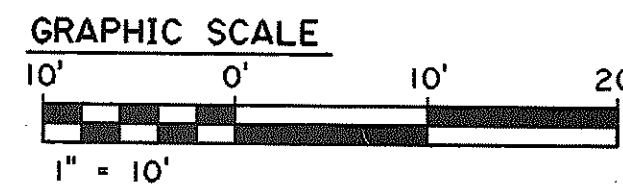

DATE	REVISION
12/29/93	REV. LOCATION OF TOP SHIELD WIRE FROM TOP OF POST (SECT 'C') PER DCN 66-027
10/26/93	CHANGED 3'-7" DIMENSION TO 3'-9" PER DCN 66-023
5-25-93	ADDED NOTE 'A' TO SECTIONS E & F PER DCN 66-008

STATE OF HAWAII
DEPARTMENT OF TRANSPORTATION
HIGHWAYS DIVISION
**HAIKU APPROACH-
SECTION 4
SUPPORT STRUCTURES
INTERSTATE ROUTE H-3
F.A.I. PROJ. NO. I-H3-1(66)**

SCALE: AS SHOWN DATE: APR. 1992
SHEET NO. SS12 OF 36 SHEETS

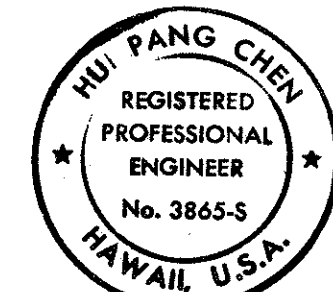


THIS WORK WAS PREPARED BY ME OR UNDER MY SUPERVISION

Hui Pang Chen

DATE	BY
12/29/93	SS12
10/26/93	SS12
5-25-93	SS12

FED. ROAD DIST. NO.	STATE	FED. AID PROJ. NO.	FISCAL YEAR	SHEET NO.	TOTAL SHEETS
HAWAII	HAW.	I-H3-1(66)	1992	375	440

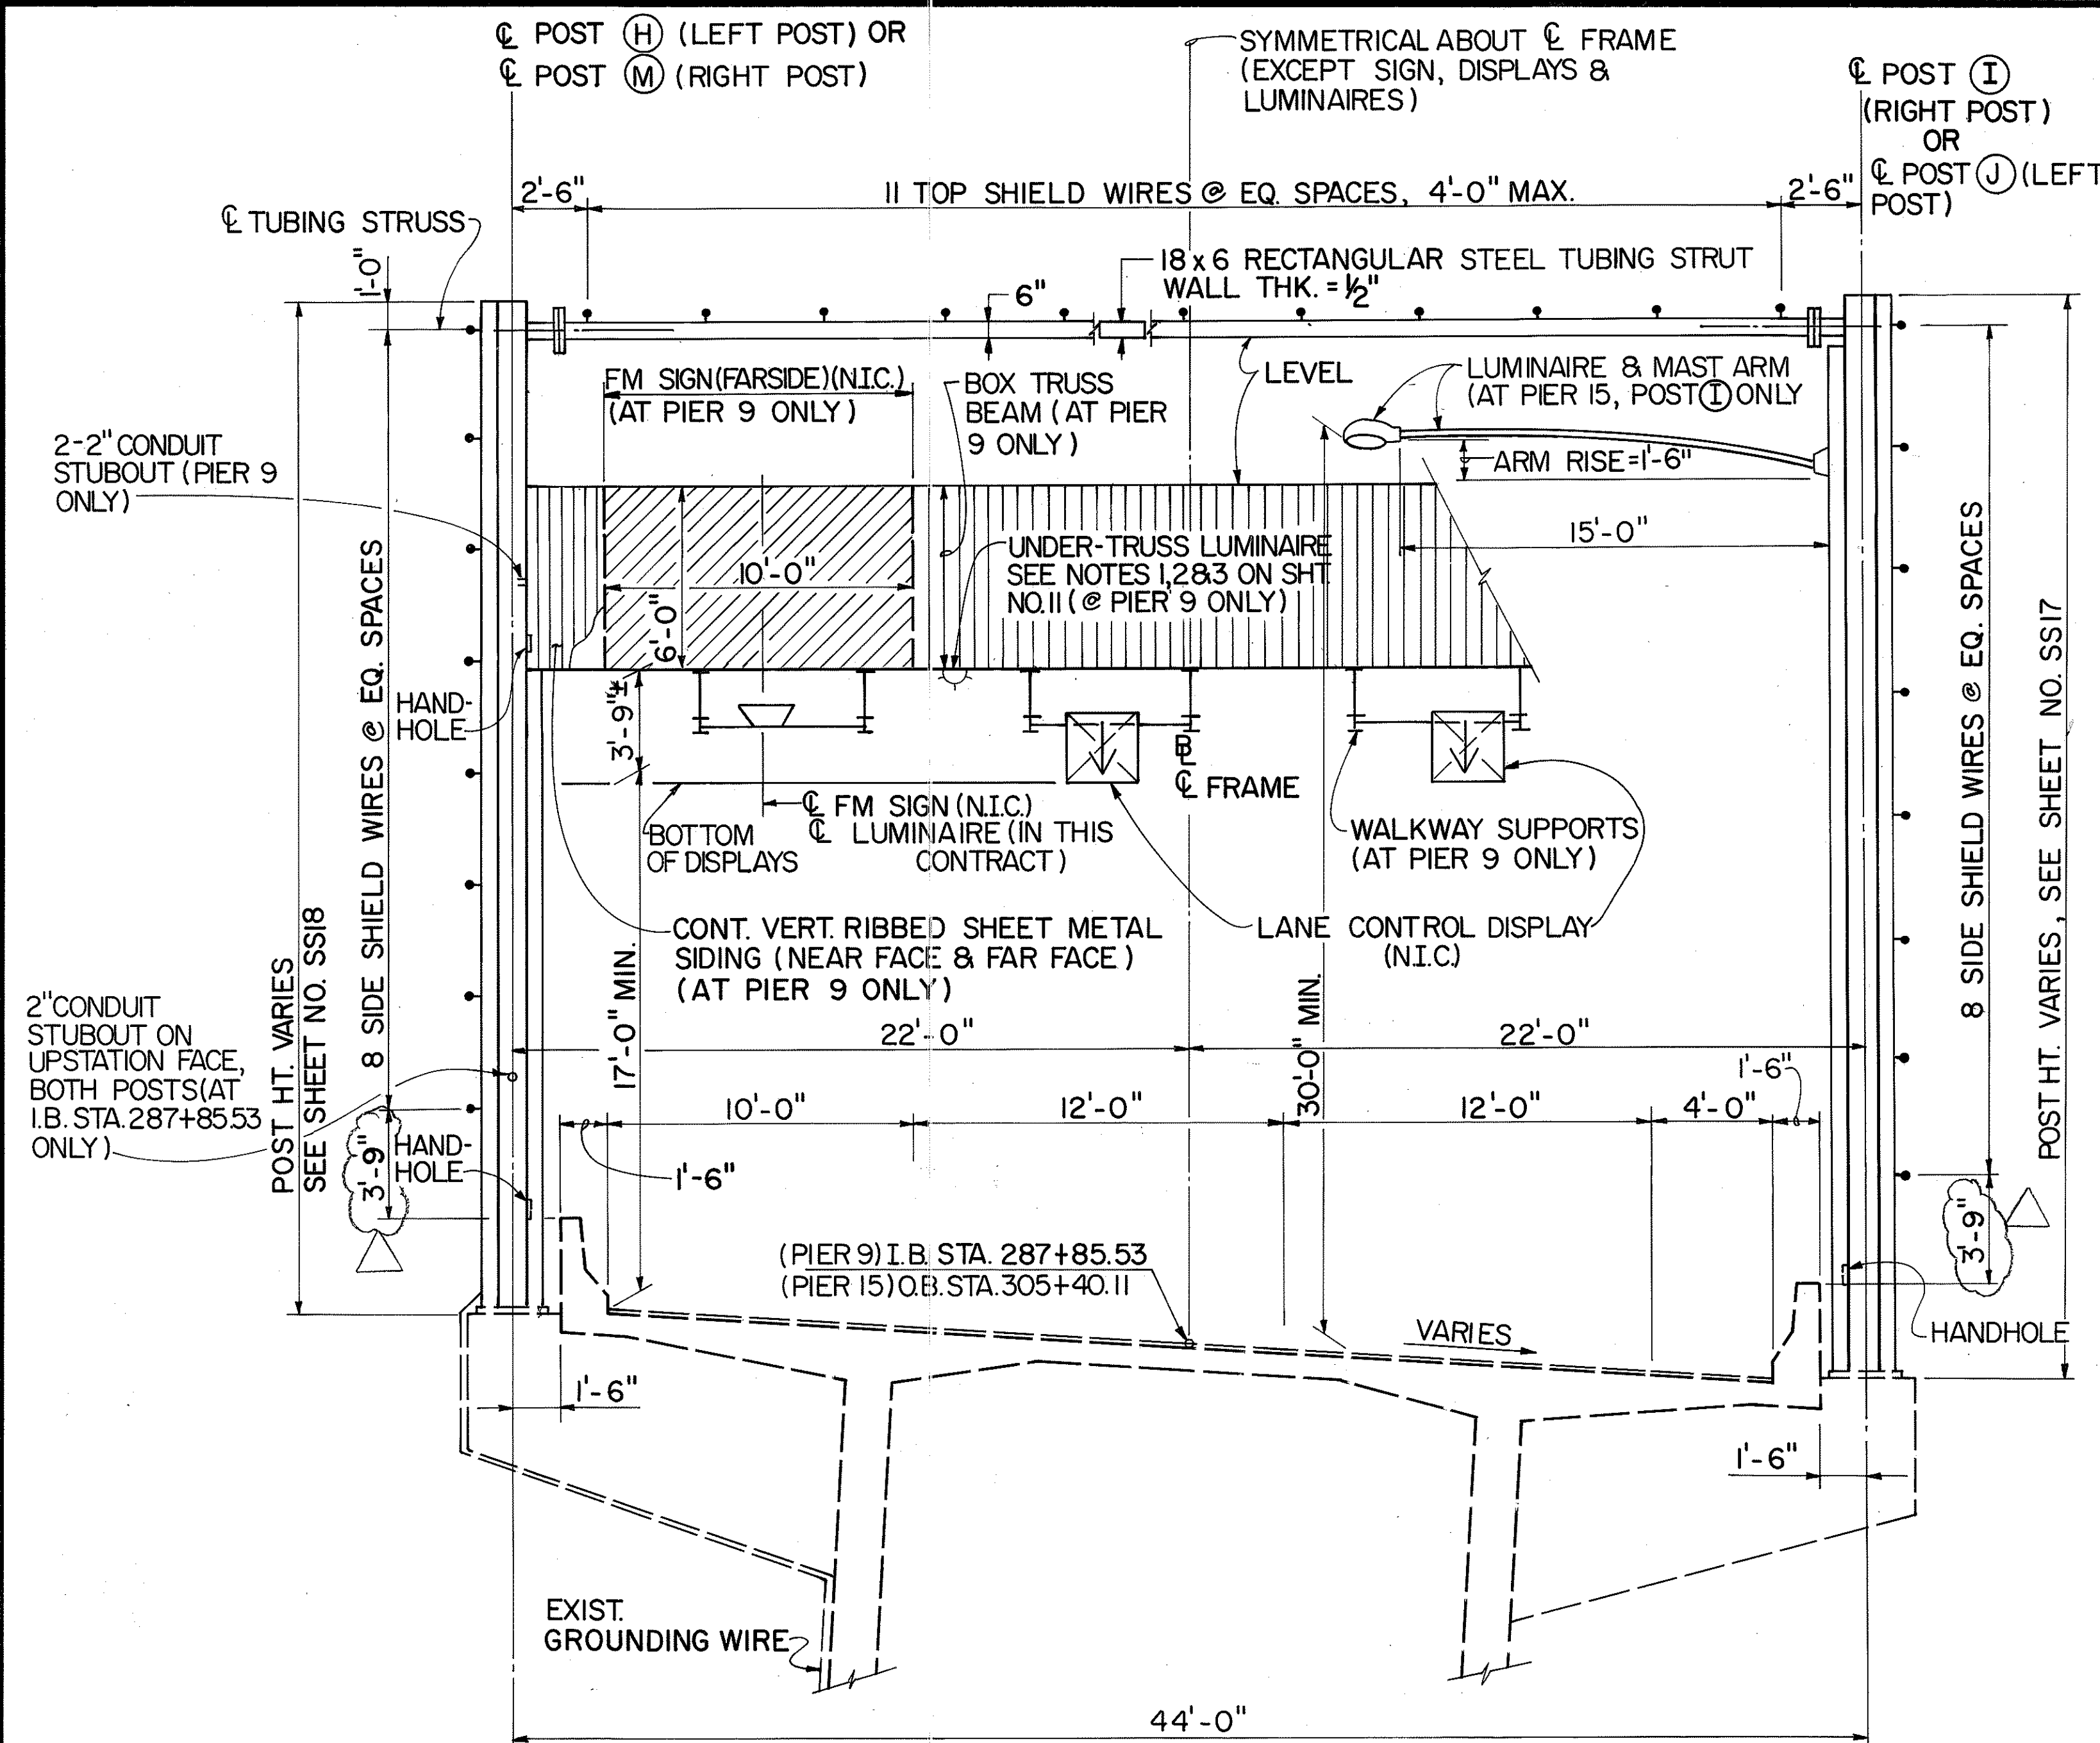


TYPICAL FOR I.B. STA. 287+85.53 (PIER 9)
(LEFT POST (H) AS SHOWN, RIGHT POST (M) SIMILAR EXCEPT OPPOSITE HAND.)

TYPICAL FOR O.B. STA. 305+40.11 (PIER 15)
(RIGHT POST (I) AS SHOWN, LEFT POST (J) SIMILAR EXCEPT OPPOSITE HAND.)

SIGN STRUCTURE / FARADAY SHIELD SUPPORT @ I.B. STA. 287+85.53 & O.B. STA. 305+40.11

SCALE: 1/4" = 1'-0"

NOTE: FOR LOCATIONS OF SIGNS, WALKWAY SUPPORTS, LANE CONTROL DISPLAYS & SIGN LUMINAIRES, SEE SHEET NO. SS26.

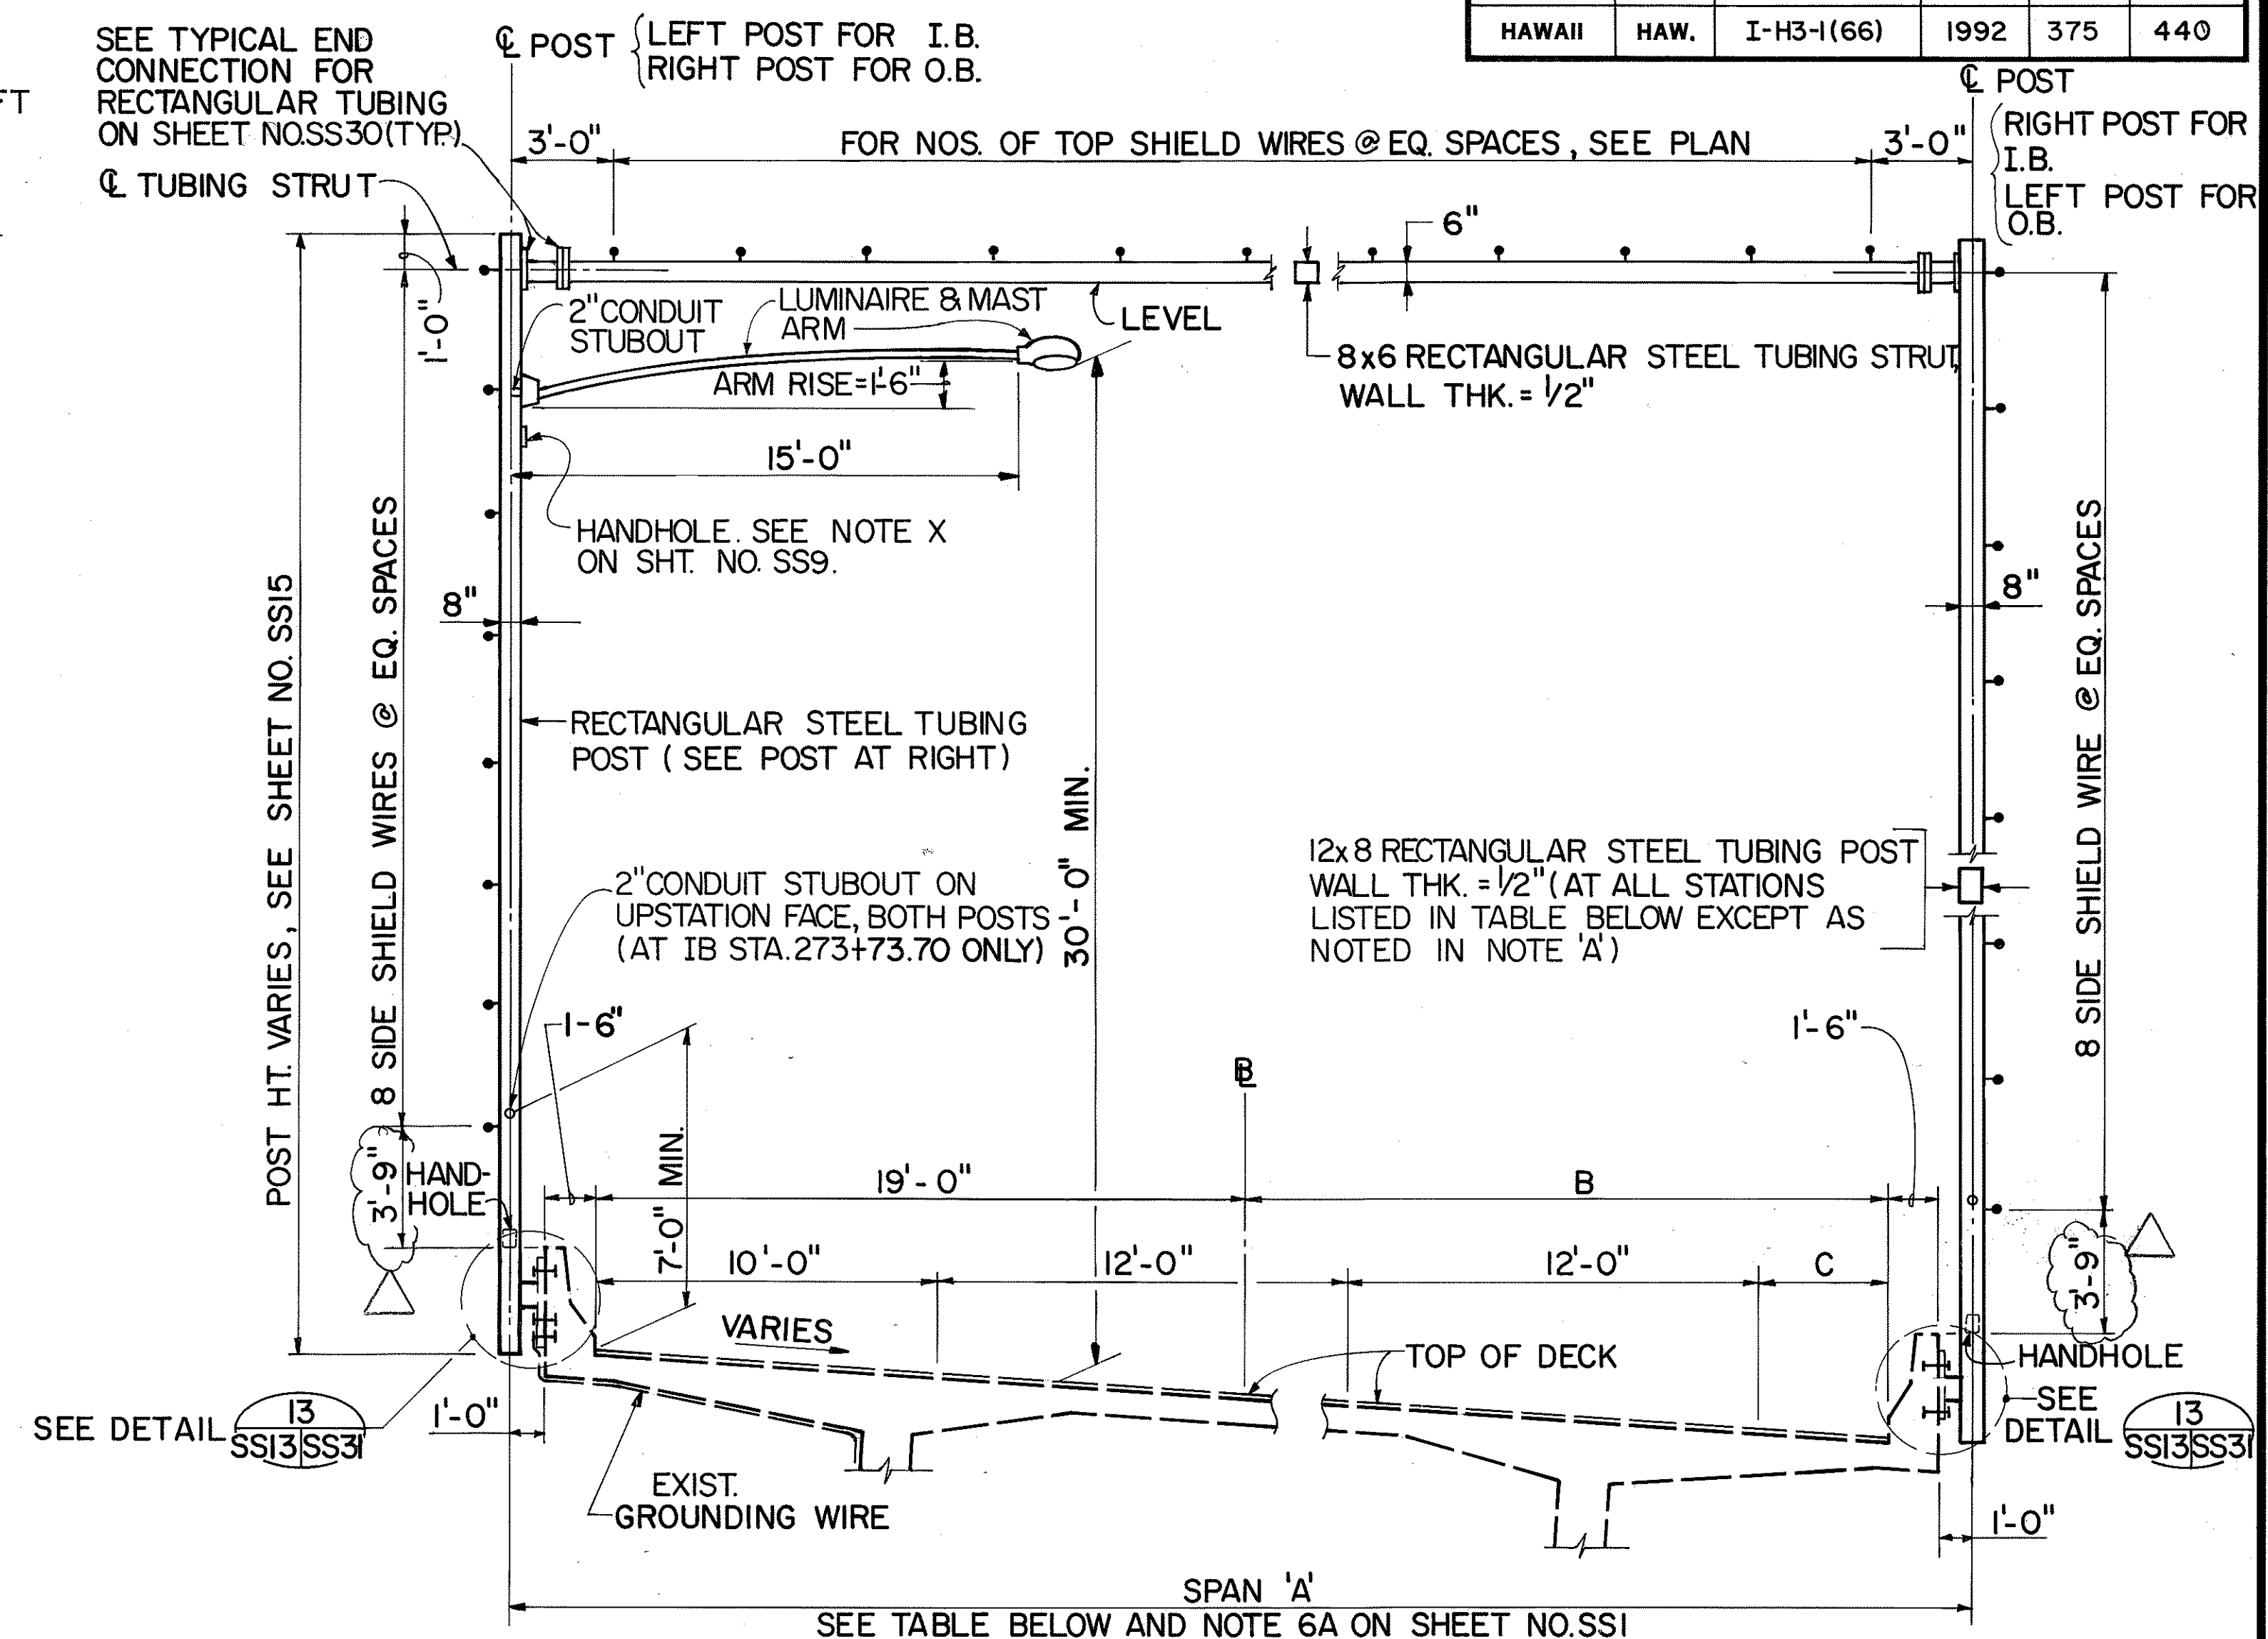


TYPICAL PARAPET MOUNTED FARADAY SHIELD SUPPORT ON WINDWARD VIADUCT

SCALE: 1/4" = 1'-0"


FARADAY SHIELD SUPPORT LOCATIONS	A	B	C
O.B. STA. 265+13.11	57.41'	33.41'	18.41'
O.B. STA. 266+07.62	52.94'	28.94'	13.94'
O.B. STA. 266+97.62 TO O.B. STA. 294+96.71*	49'	25'	10'
O.B. STA. 295+93.28 TO O.B. STA. 304+39.28 AND I.B. STA. 266+26.05 TO I.B. STA. 304+34.70*	43'	19'	4'
I.B. STA. 265+34.70	46'	22'	7'

*EXCLUDE FARADAY SHIELD SUPPORT LOCATIONS WITH SIGN STRUCTURES (O.B. STA. 273+70.11, O.B. STA. 305+40.11, I.B. STA. 279+45.53, I.B. STA. 287+85.53, & I.B. STA. 305+35.53)

NOTE 'A': PROVIDE 16x8 RECTANGULAR STEEL TUBING POST WALL THK. = 1/2" AT O.B. STA. 297+66.79, O.B. STA. 304+39.28, I.B. STA. 273+73.70 & I.B. STA. 297+57.20

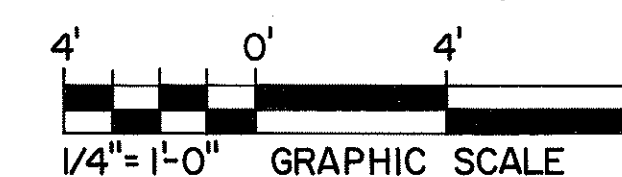

NOTE: TYPICAL I.B. FARADAY SHIELD SUPPORT SHOWN. TYPICAL O.B. FARADAY SHIELD SUPPORT IS OPPOSITE-HAND OF I.B. SUPPORT.

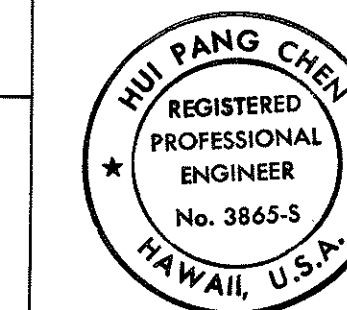

THIS WORK WAS PREPARED BY ME OR UNDER MY SUPERVISION.
Hui Pang Chen


DATE	REVISION
10/26/93	CHANGED 3'-7" DIMENSION TO 3'-9" PER DCN 66-023

STATE OF HAWAII
DEPARTMENT OF TRANSPORTATION
HIGHWAYS DIVISION
**HAIKU APPROACH -
SECTION 5**
SUPPORT STRUCTURES
INTERSTATE ROUTE H-3
F.A.I. PROJ. NO. I-H3-1(66)

SCALE: AS SHOWN DATE: APR. 1992
SHEET No. SS3 OF 36 SHEETS

ORIGINAL PLAN	DATE
DESIGNED BY	1/90
TRACED BY	1/90
QUANTITIES BY	3/92
CHECKED BY	1/90

FED. ROAD DIST. NO.	STATE	FED. AID PROJ. NO.	FISCAL YEAR	SHEET NO.	TOTAL SHEETS
HAWAII	HAW.	I-H3-1(66)	1992	376	440

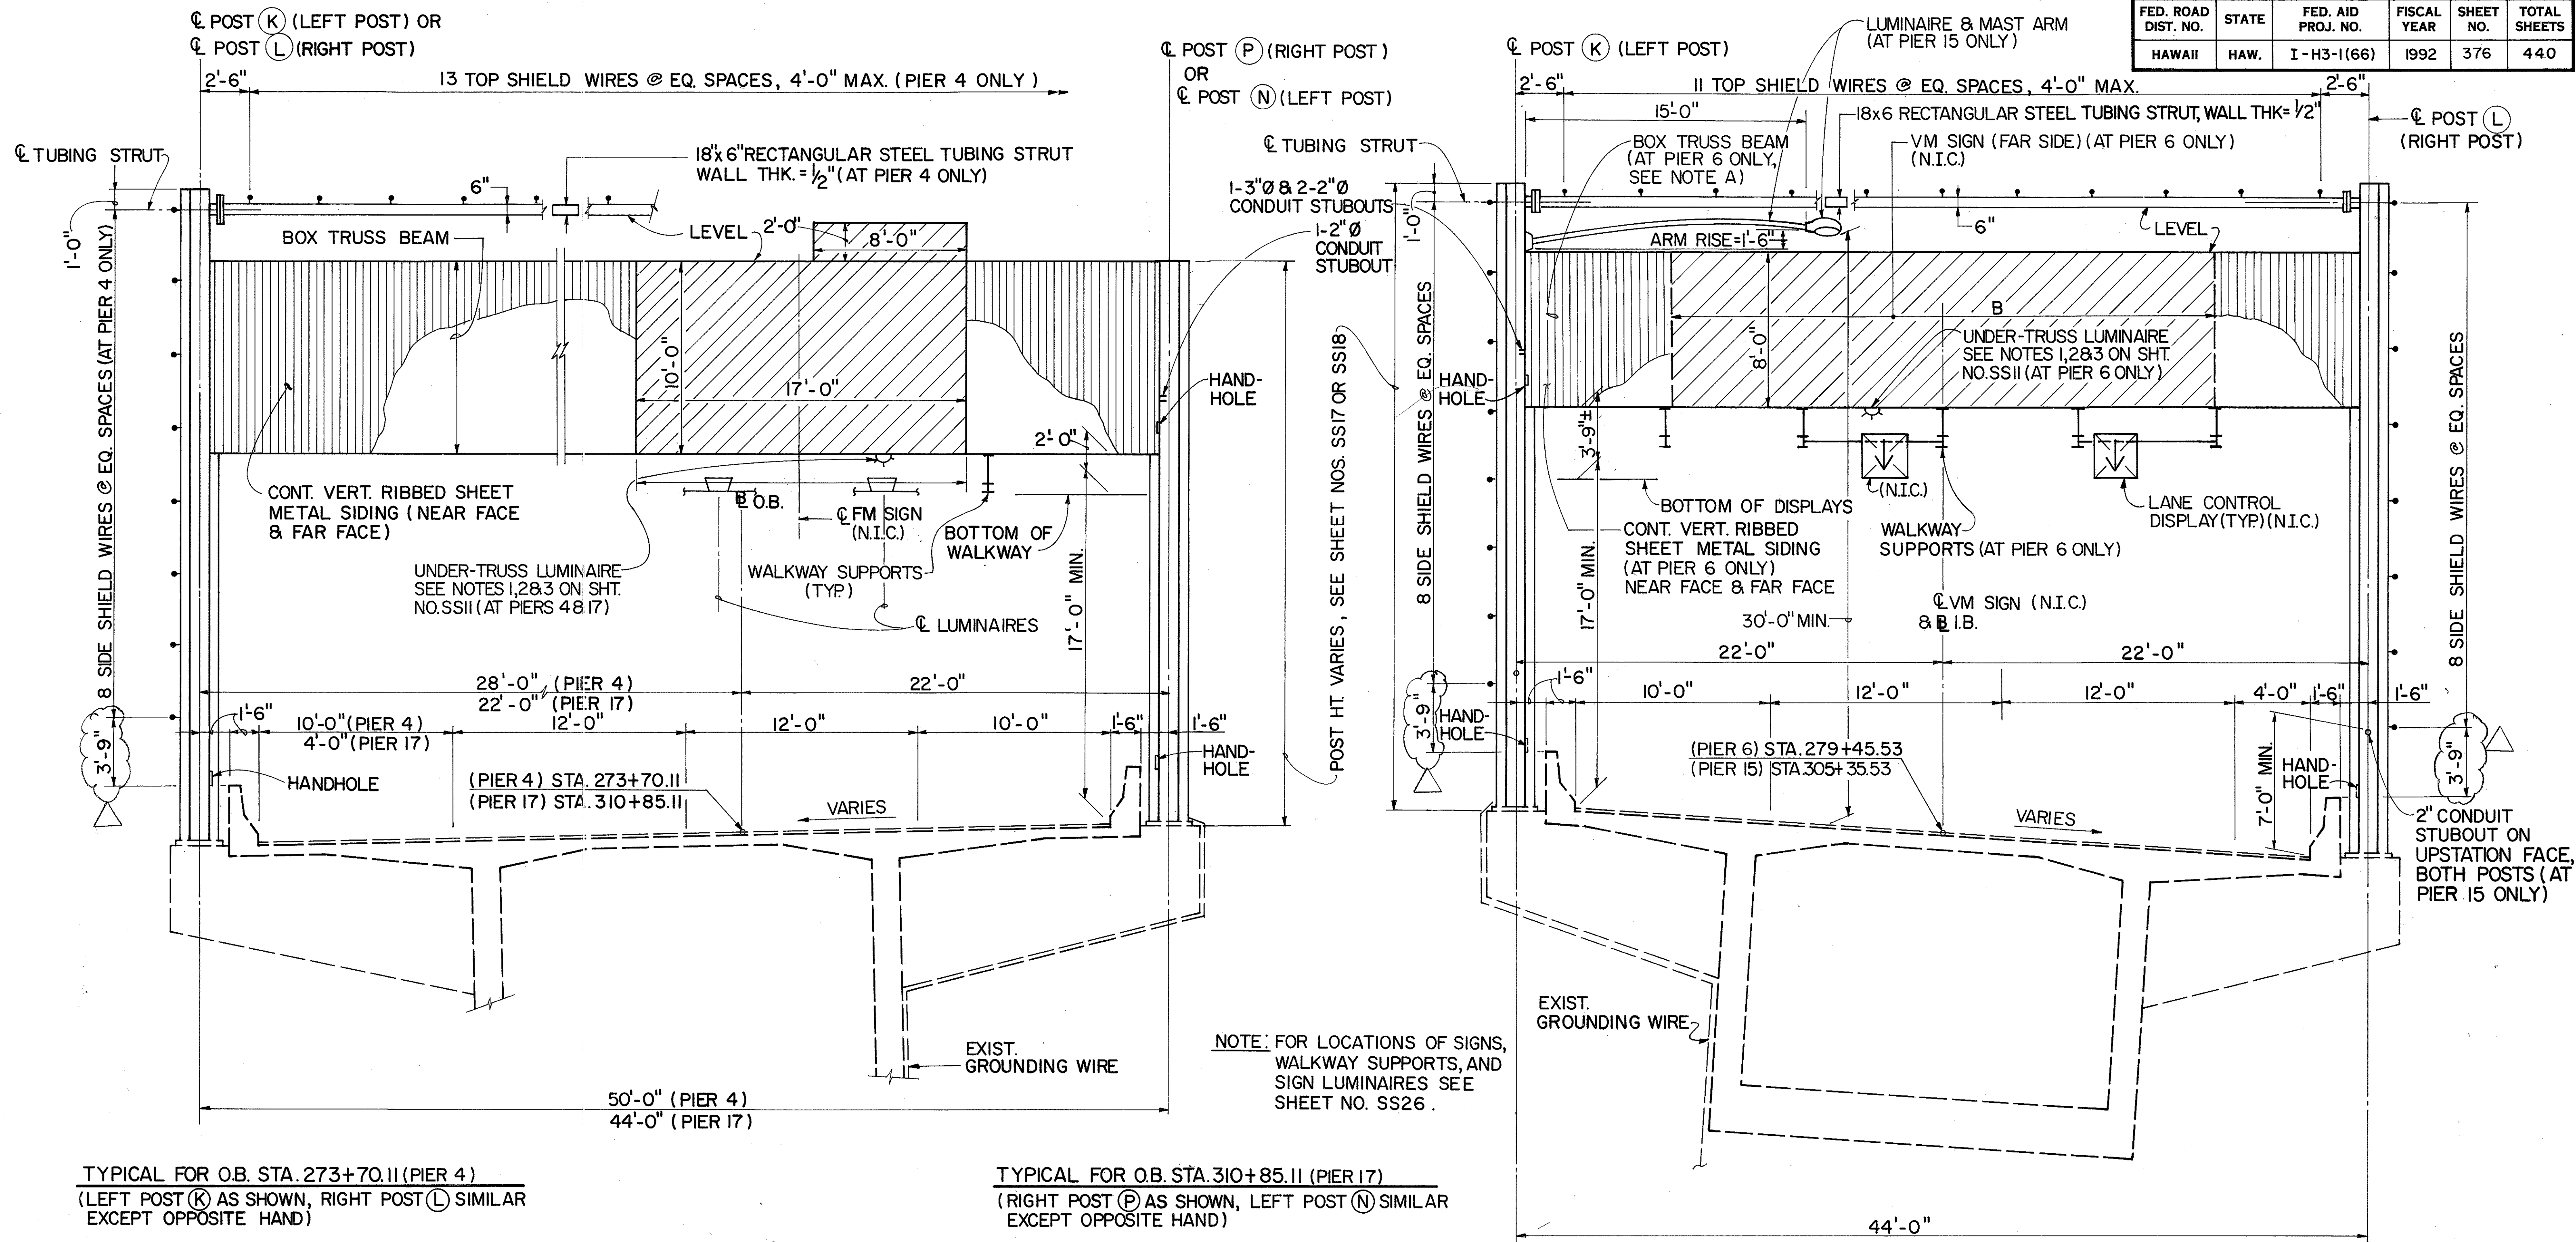



TYPICAL FOR O.B. STA. 273+70.11 (PIER 4)
(LEFT POST (K) AS SHOWN, RIGHT POST (L) SIMILAR
EXCEPT OPPOSITE HAND)

TYPICAL FOR O.B. STA. 310+85.11 (PIER 17)
(RIGHT POST (P) AS SHOWN, LEFT POST (N) SIMILAR
EXCEPT OPPOSITE HAND)

**SIGN STRUCTURE / FARADAY SHIELD SUPPORT @ O.B. STA. 273+70.11
& SIGN STRUCTURE @ O.B. STA. 310+85.11**
SCALE: 1/4" = 1'-0"

**SIGN STRUCTURE / FARADAY SHIELD SUPPORT
@ I.B. STA. 279+45.53 (PIER 6)
& @ I.B. STA. 305+35.53 (PIER 15)**
SCALE: 1/4" = 1'-0"

NOTE 'A':
AT PIER 15, PROVIDE TOP & BOTTOM HINGE
CONNECTIONS AT POSTS FOR FUTURE
INSTALLATION OF BOX TRUSS BEAM SIMILAR
TO PIER 6.

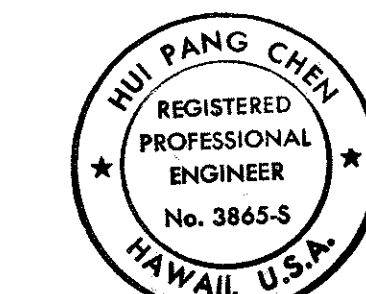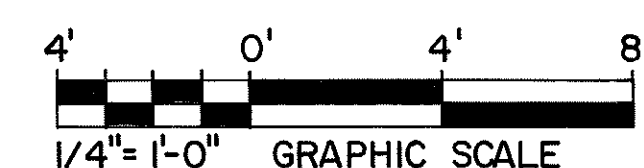

THIS WORK WAS PREPARED BY ME
OR UNDER MY SUPERVISION.

Hui Pang Chen


10/26/93	CHANGED 3'-7" DIMENSION TO 3'-9" PER DCN 66-023
DATE	REVISION
STATE OF HAWAII DEPARTMENT OF TRANSPORTATION HIGHWAYS DIVISION	
HAIKU APPROACH - SECTION 6 SUPPORT STRUCTURES	
INTERSTATE ROUTE H-3 F.A.I. PROJ. NO. I-H3-1(66)	
SCALE: AS SHOWN	DATE: APR. 1992
SHEET NO. SS14 OF 36 SHEETS	

FED. ROAD DIST. NO.	STATE	FED. AID PROJ. NO.	FISCAL YEAR	SHEET NO.	TOTAL SHEETS
HAWAII	HAW.	I-H3-1(66)	1992	377	440

I.B. FARADAY SHIELD SUPPORT LOCATIONS	POST HEIGHT "B"	
	LEFT POST	RIGHT POST
656 + 52.67	SEE SHEET NO. SS12	
257 + 51.00	32' - 9"	34' - 8"
258 + 66.00		34' - 8"
259 + 70.00		34' - 9"
260 + 70.00		34' - 8"
261 + 70.00		34' - 9"
265 + 34.70		34' - 5"
266 + 26.05		33' - 11"
267 + 19.55	32' - 9"	33' - 5"
268 + 09.70	32' - 11"	32' - 9"
269 + 07.04	33' - 4"	
270 + 04.70	33' - 4"	
271 + 05.50	33' - 4"	
271 + 97.04	33' - 7"	
272 + 84.70	35' - 3"	
273 + 73.70	34' - 6"	
274 + 77.04	35' - 4"	
275 + 74.70		
276 + 65.77		
277 + 57.34		
278 + 54.70		
280 + 37.04		
281 + 34.70		
282 + 25.53		
283 + 17.04		
284 + 14.70		
285 + 05.53		
285 + 97.07		
286 + 94.70	35' - 4"	
288 + 87.11	34' - 4"	
289 + 84.70	33' - 6"	
290 + 75.53	33' - 4"	
291 + 67.15	33' - 4"	
292 + 63.70	33' - 4"	
293 + 63.70	33' - 0"	32' - 9"
294 + 57.19	32' - 9"	33' - 3"
295 + 53.70		34' - 1"
296 + 53.70		34' - 6"
297 + 57.20		34' - 6"
298 + 54.70		34' - 6"
299 + 45.53		34' - 6"
300 + 37.20		34' - 6"
301 + 34.70		34' - 9"
302 + 35.53		35' - 1"
303 + 37.20		35' - 2"
304 + 34.70	32' - 9"	35' - 2"

O.B. FARADAY SHIELD SUPPORT LOCATIONS	POST HEIGHT "B"	
	LEFT POST	RIGHT POST
657 + 42.67	SEE SHEET NO. SS12	
258 + 40.00	32' - 9"	34' - 7"
259 + 40.00	32' - 9"	31' - 6"
260 + 40.00	32' - 9"	31' - 6"
261 + 40.00	SEE SHEET NO. SS10	
264 + 25.61	32' - 7"	31' - 7"
265 + 13.11	32' - 9"	34' - 7"
266 + 07.62		34' - 6"
266 + 97.62		34' - 6"
267 + 91.28		34' - 6"
268 + 87.62		34' - 0"
269 + 83.28	32' - 9"	33' - 2"
270 + 83.58	33' - 3"	32' - 9"
271 + 76.62	34' - 2"	
272 + 69.28	35' - 1"	
274 + 61.54	35' - 8"	
275 + 59.28		
276 + 48.28		
277 + 41.50		
278 + 27.50		
279 + 22.28		
280 + 21.49		
281 + 17.28		
282 + 04.28		
282 + 92.49		
283 + 84.49	35' - 8"	
284 + 78.28	35' - 0"	
285 + 74.49	35' - 8"	
286 + 63.49	35' - 8"	
287 + 59.28	35' - 8"	
288 + 48.54	35' - 4"	
289 + 42.54	34' - 4"	
290 + 34.28	33' - 2"	32' - 9"
291 + 27.62	32' - 9"	33' - 3"
292 + 16.62		33' - 4"
293 + 14.28		33' - 4"
294 + 03.28		33' - 4"
294 + 96.71		33' - 5"
295 + 93.28		34' - 1"
296 + 85.28		34' - 6"
297 + 66.79		34' - 6"
298 + 62.28		34' - 7"
299 + 57.28		34' - 7"
300 + 56.82		34' - 7"
301 + 53.28		34' - 10"
302 + 45.28		35' - 2"
303 + 36.82		35' - 3"
304 + 39.28	32' - 9"	35' - 3"

DATE	3/92
SURVEY PLOTTED BY	CHUN
DRAWN BY	CHUN
DESIGNED BY	CHUN
QUANTITIES BY	CHUN
CHECKED BY	CHUN
ORIGINAL PLAN	
NOTE BOOK	
No.	

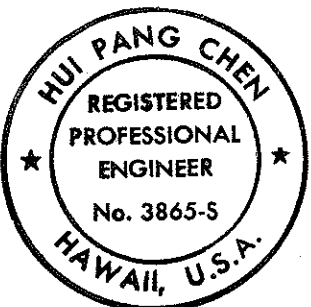

THIS WORK WAS PREPARED BY ME
OR UNDER MY SUPERVISION.
Hui Pang Chen

DATE	REVISION
STATE OF HAWAII DEPARTMENT OF TRANSPORTATION HIGHWAYS DIVISION	
SUPPORT POST SCHEDULE	
SUPPORT STRUCTURES INTERSTATE ROUTE H-3 F.A.I. PROJ. NO. I-H3-1(66)	
SCALE: NO SCALE	DATE: APR. 1992
SHEET No.SS15 OF 36 SHEETS	

SURVEY PLOTTED BY: DATE: 1/7/92
 DRAWN BY: K. WADA
 DESIGNED BY: K. WADA
 QUANTITIES BY: S. CHEN
 CHECKED BY: S. CHEN
 ORIGINAL PLAN: 1/7/92
 NOTE BOOK: 1/7/92

FED. ROAD DIST. NO.	STATE	FED. AID PROJ. NO.	FISCAL YEAR	SHEET NO.	TOTAL SHEETS
HAWAII	HAW.	I-H3-1(66)	1992	378	440

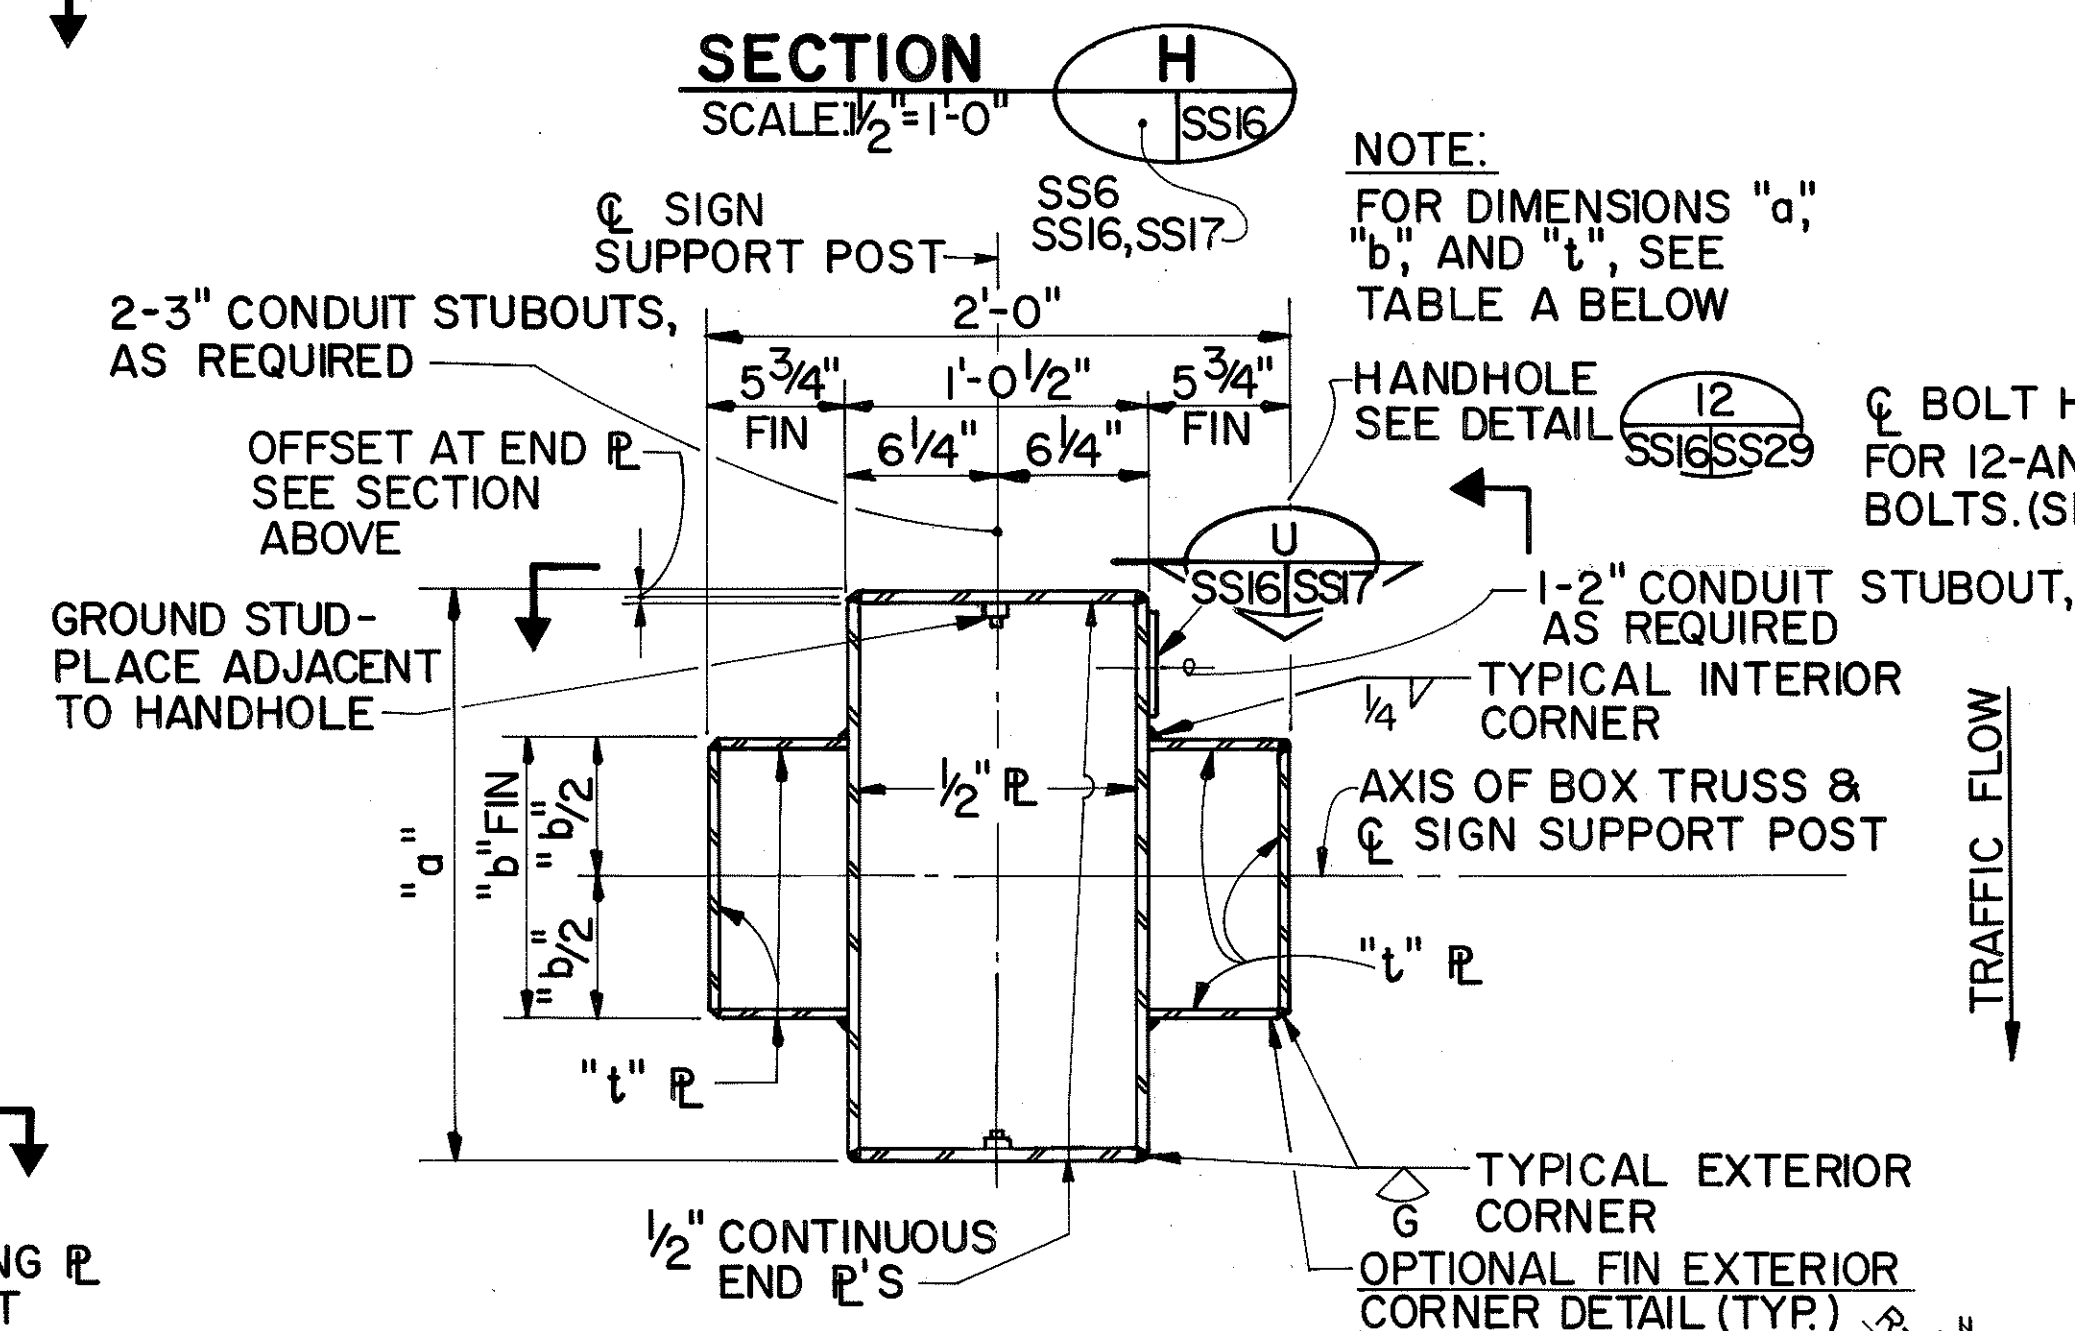
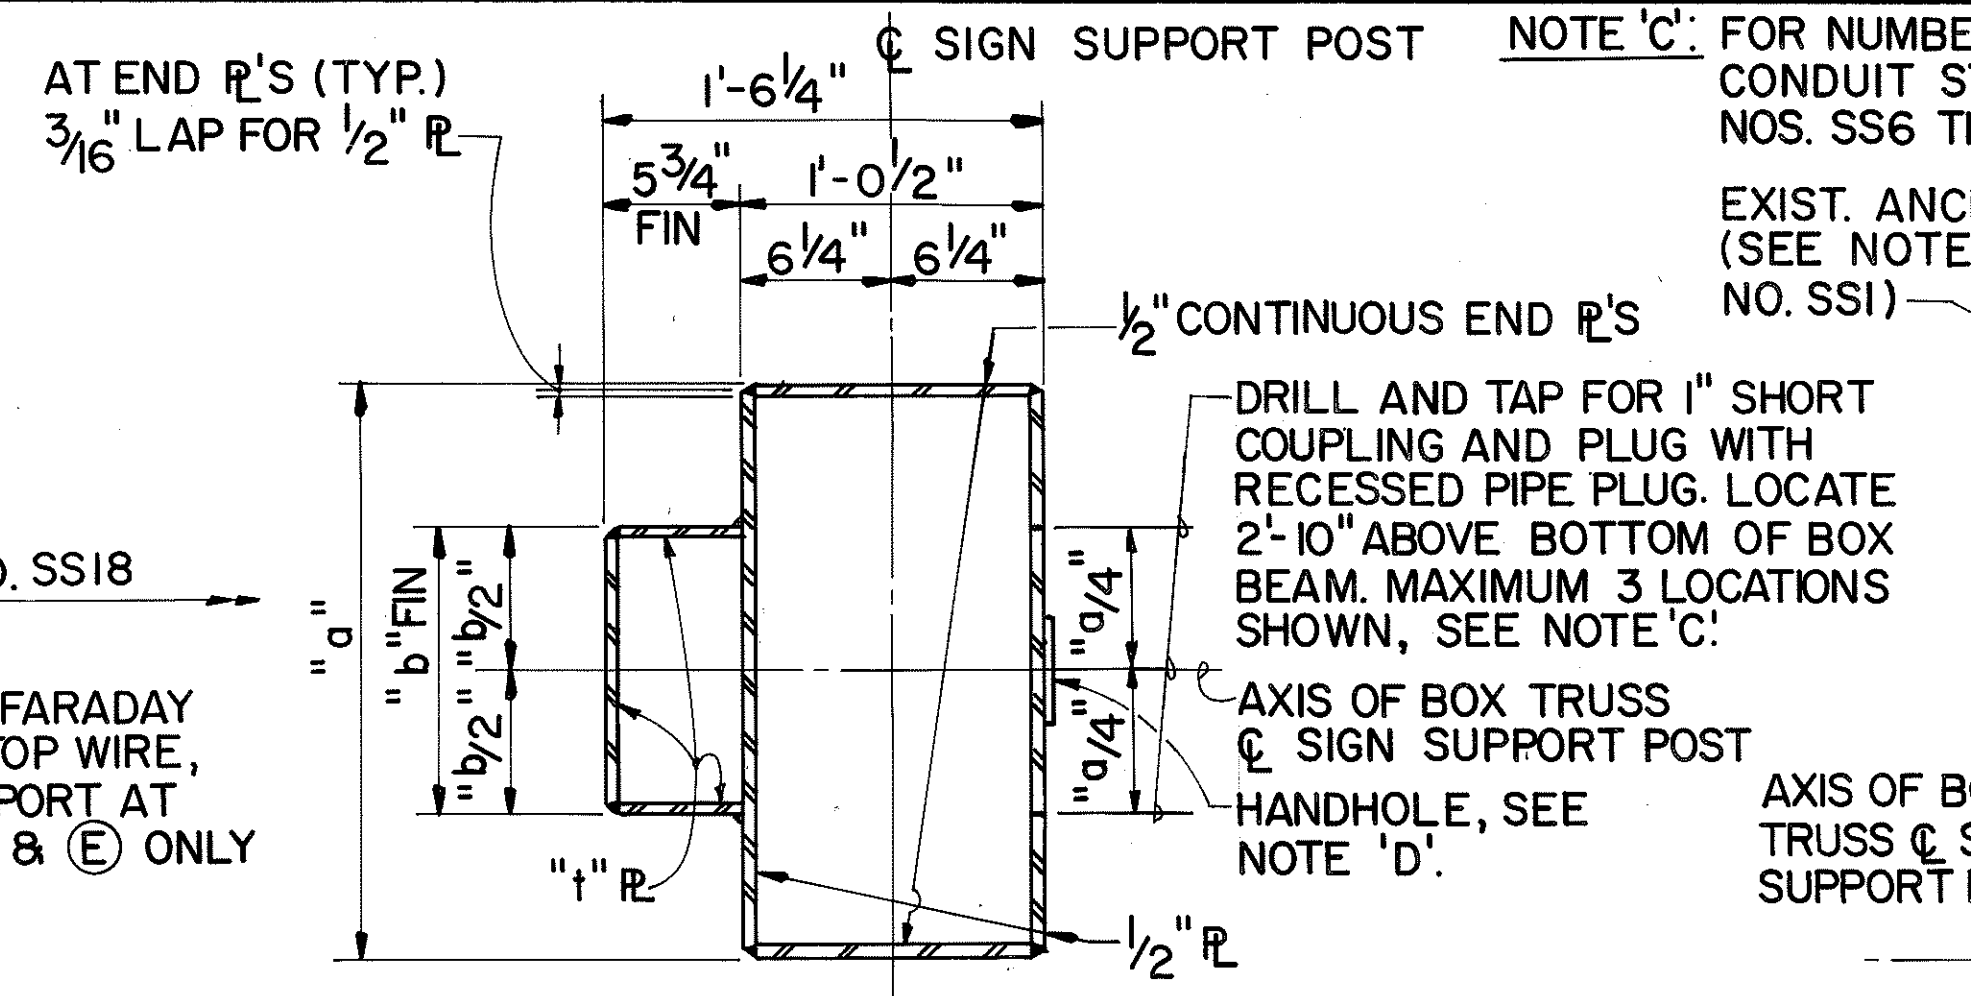
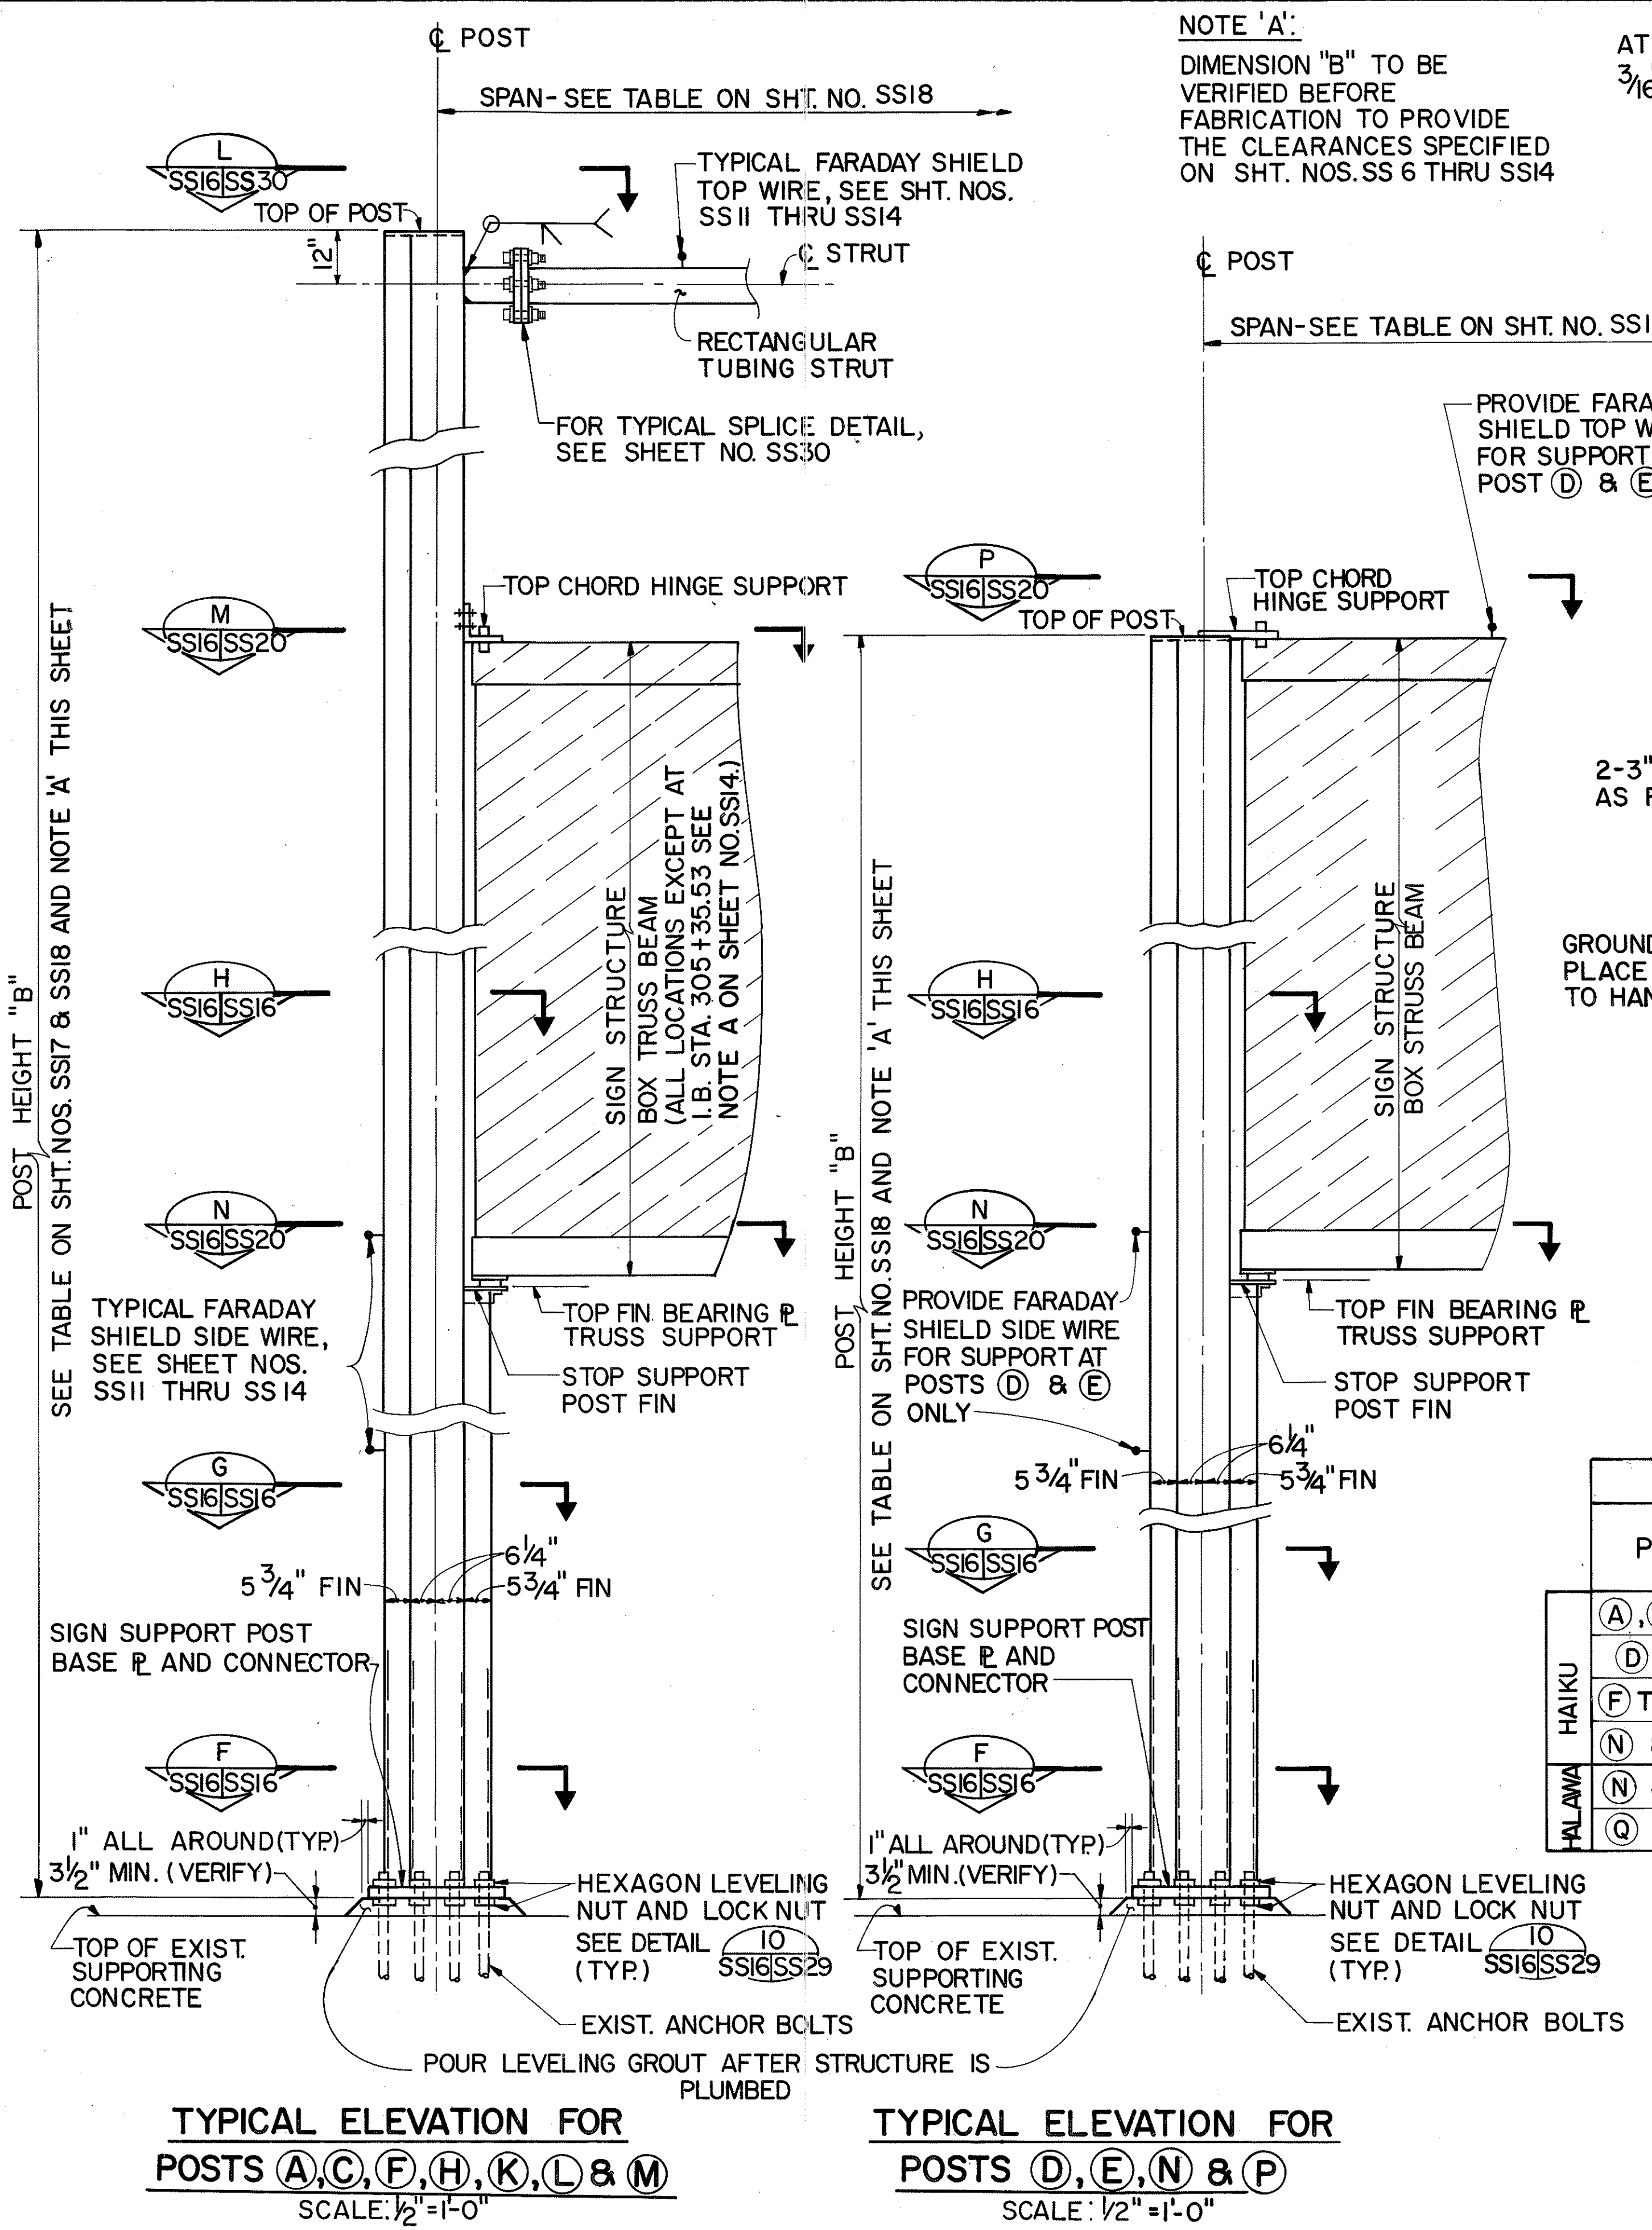


TABLE A

POST	"a"	"b"	"t"
HAUKU (A, B & C)	2'-6"	1'-5 3/4"	1/2"
(D & E)	3'-0"	1'-11 3/4"	1/2"
(F THRU M)	2'-0"	1'-11 3/4"	3/8"
(N & P)	2'-0"	1'-11 3/4"	3/8"
HALAWA (N & P)	2'-0"	1'-11 3/4"	3/8"
(Q)	3'-0"	1'-11 3/4"	1/2"




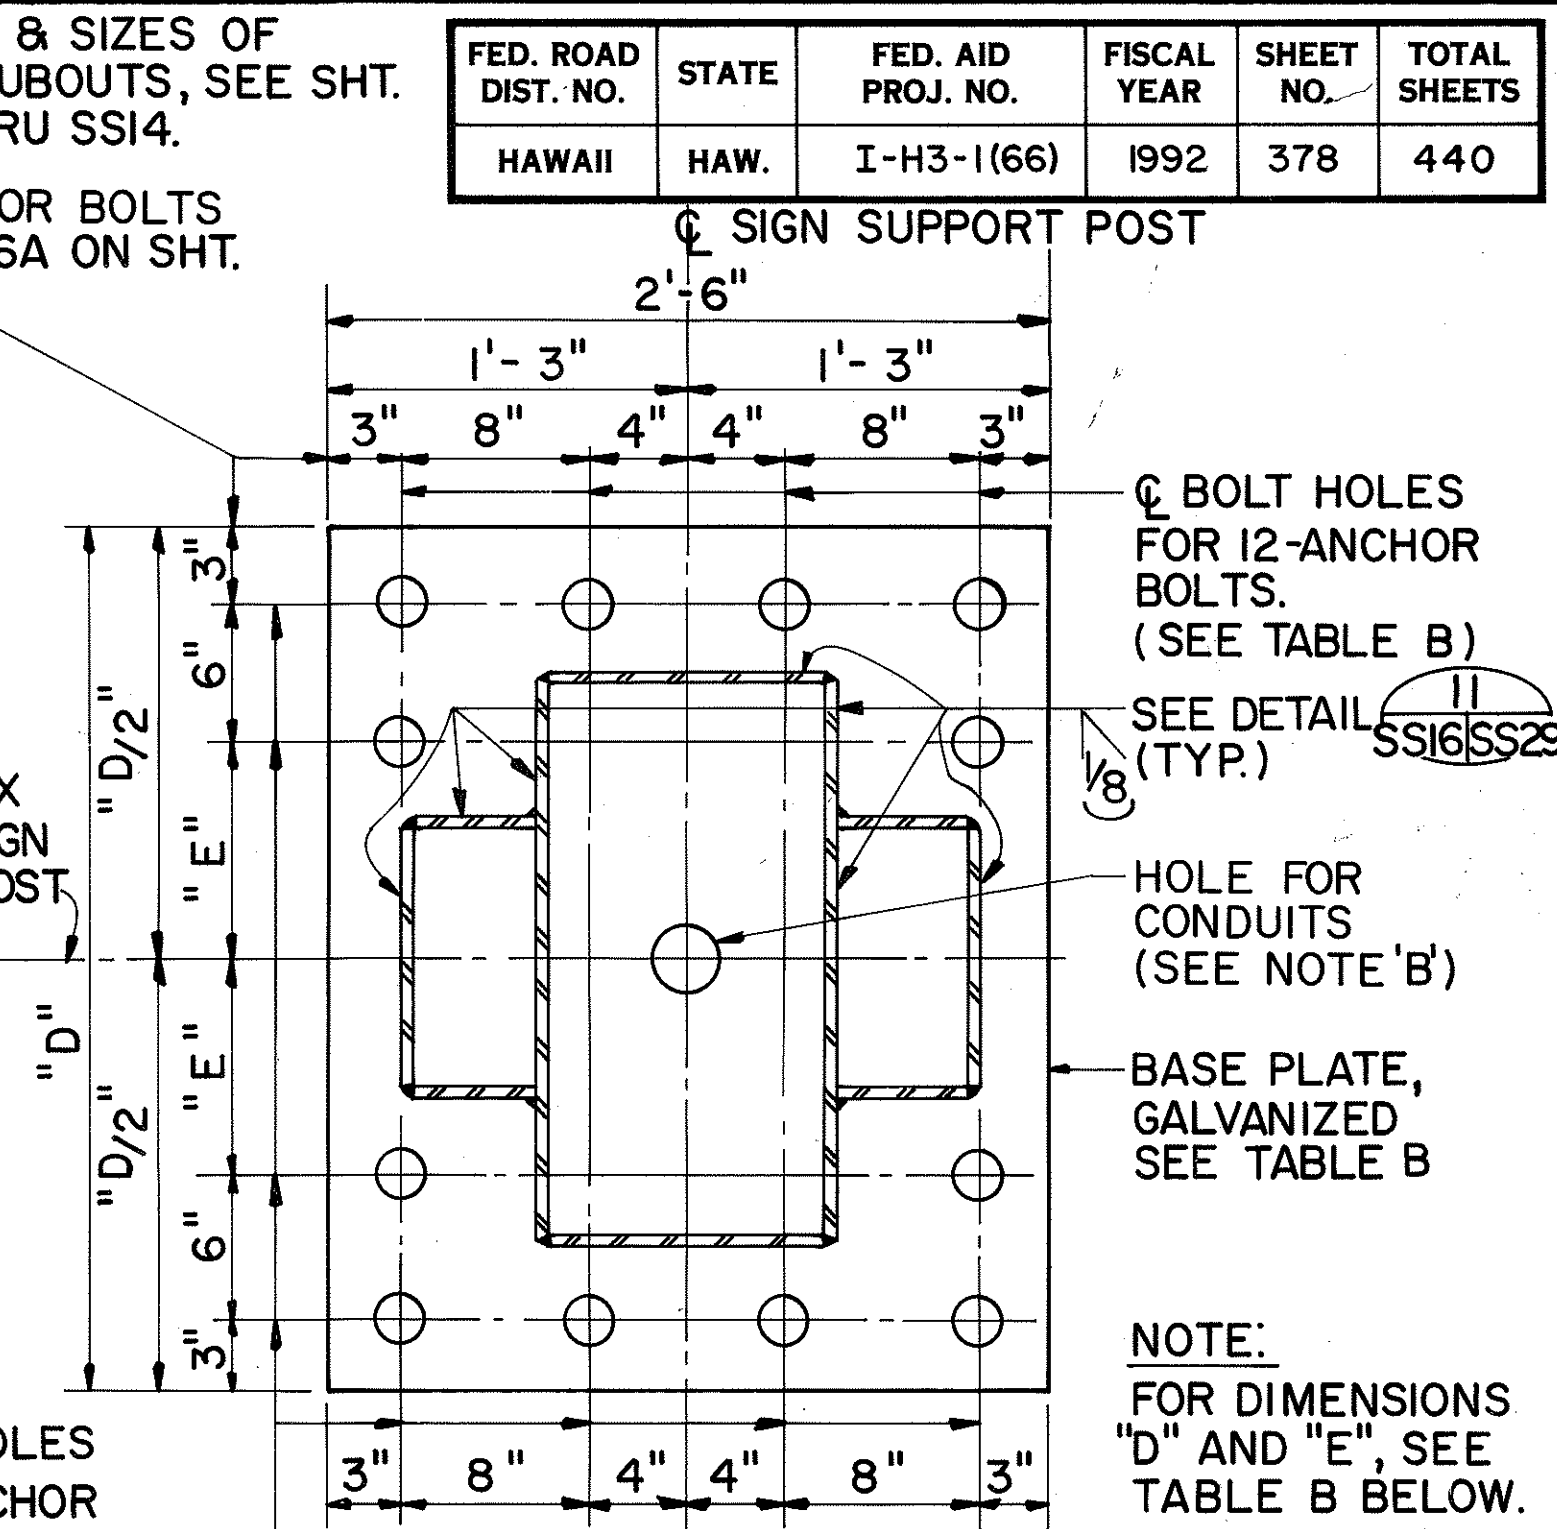


TABLE B

POST	BASE PLATE			BOLT HOLE SIZE
	"D"	THICKNESS	"E"	
HAUKU (A, B & C)	3'-6"	3"	1'-0"	2 5/8" Ø
(D & E)	4'-0"	3 1/4"	1'-3"	2 5/8" Ø
(F & G)	3'-0"	2 1/2"	0'-9"	2 5/8" Ø
(H THRU M)	3'-0"	2 3/4"	0'-9"	2 3/8" Ø
(N & P)	3'-0"	2 1/2"	0'-9"	2 3/8" Ø
HALAWA (N & P)	3'-0"	2 1/2"	0'-9"	2 3/8" Ø
(Q)	4'-0"	3"	1'-3"	2 5/8" Ø

NOTE 'B': THE CONTRACTOR SHALL VERIFY THE NUMBER & SIZES OF CONDUITS IN THE FIELD PRIOR TO FABRICATION.
 NOTE 'D': PLACE HANDHOLE IN SUPPORT POSTS WHERE CONDUIT STUBOUTS ARE PROVIDED. LOCATE HANDHOLE SO THAT BOTTOM OF HANDHOLE COVER IS 1'-2" ABOVE BOTTOM OF BOX BEAM & CENTERED ABOUT C SUPPORT POST.

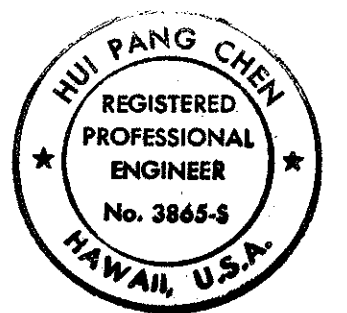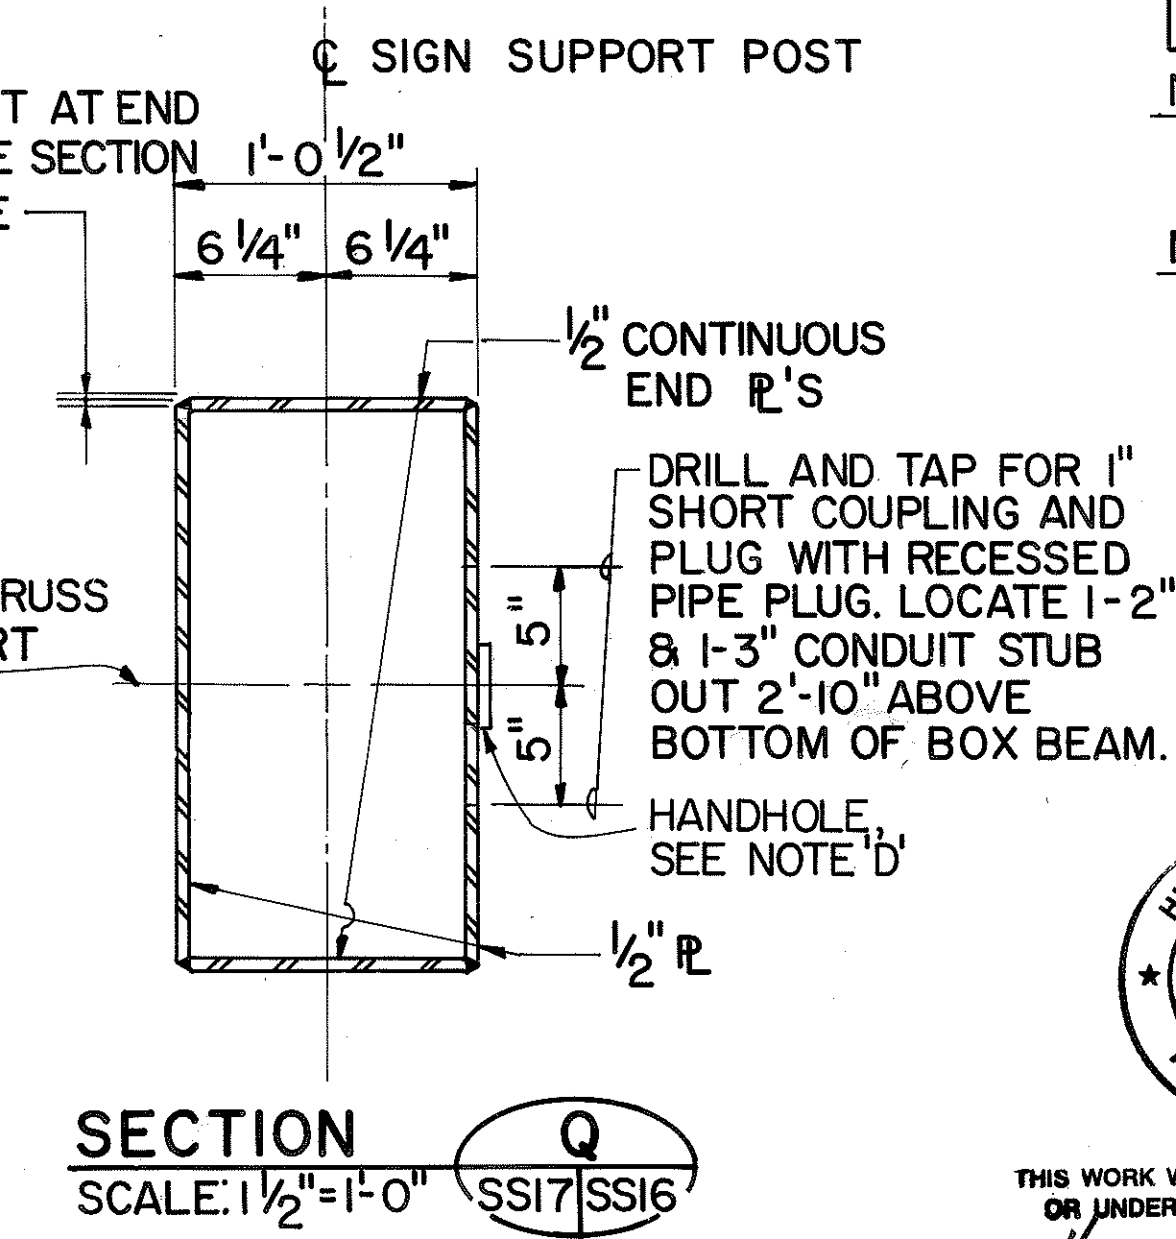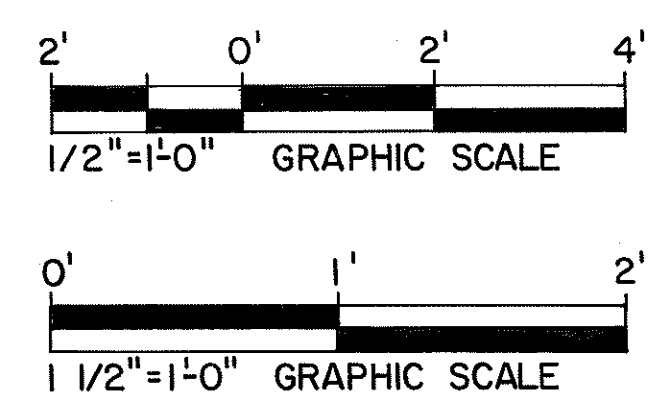


1/7/94 REV. BOLT HOLE SIZE PER DCN 66-031
 DATE REVISION
 STATE OF HAWAII
 DEPARTMENT OF TRANSPORTATION
 HIGHWAYS DIVISION
SUPPORT POST DETAILS-1
 SUPPORT STRUCTURES
 INTERSTATE ROUTE H-3
 F.A.I. PROJ. NO. I-H3-1(66)
 SCALE: AS SHOWN DATE: APR. 1992
 SHEET NO. SS16 OF 36 SHEETS

FED. ROAD DIST. NO.	STATE	FED. AID PROJ. NO.	FISCAL YEAR	SHEET NO.	TOTAL SHEETS
HAWAII	HAW.	I-H3-1(66)	1992	379	440

SPAN-SEE TABLE ON SHT. NO. SS18

POST

SPAN-SEE TABLE ON SHT. NO. SS18

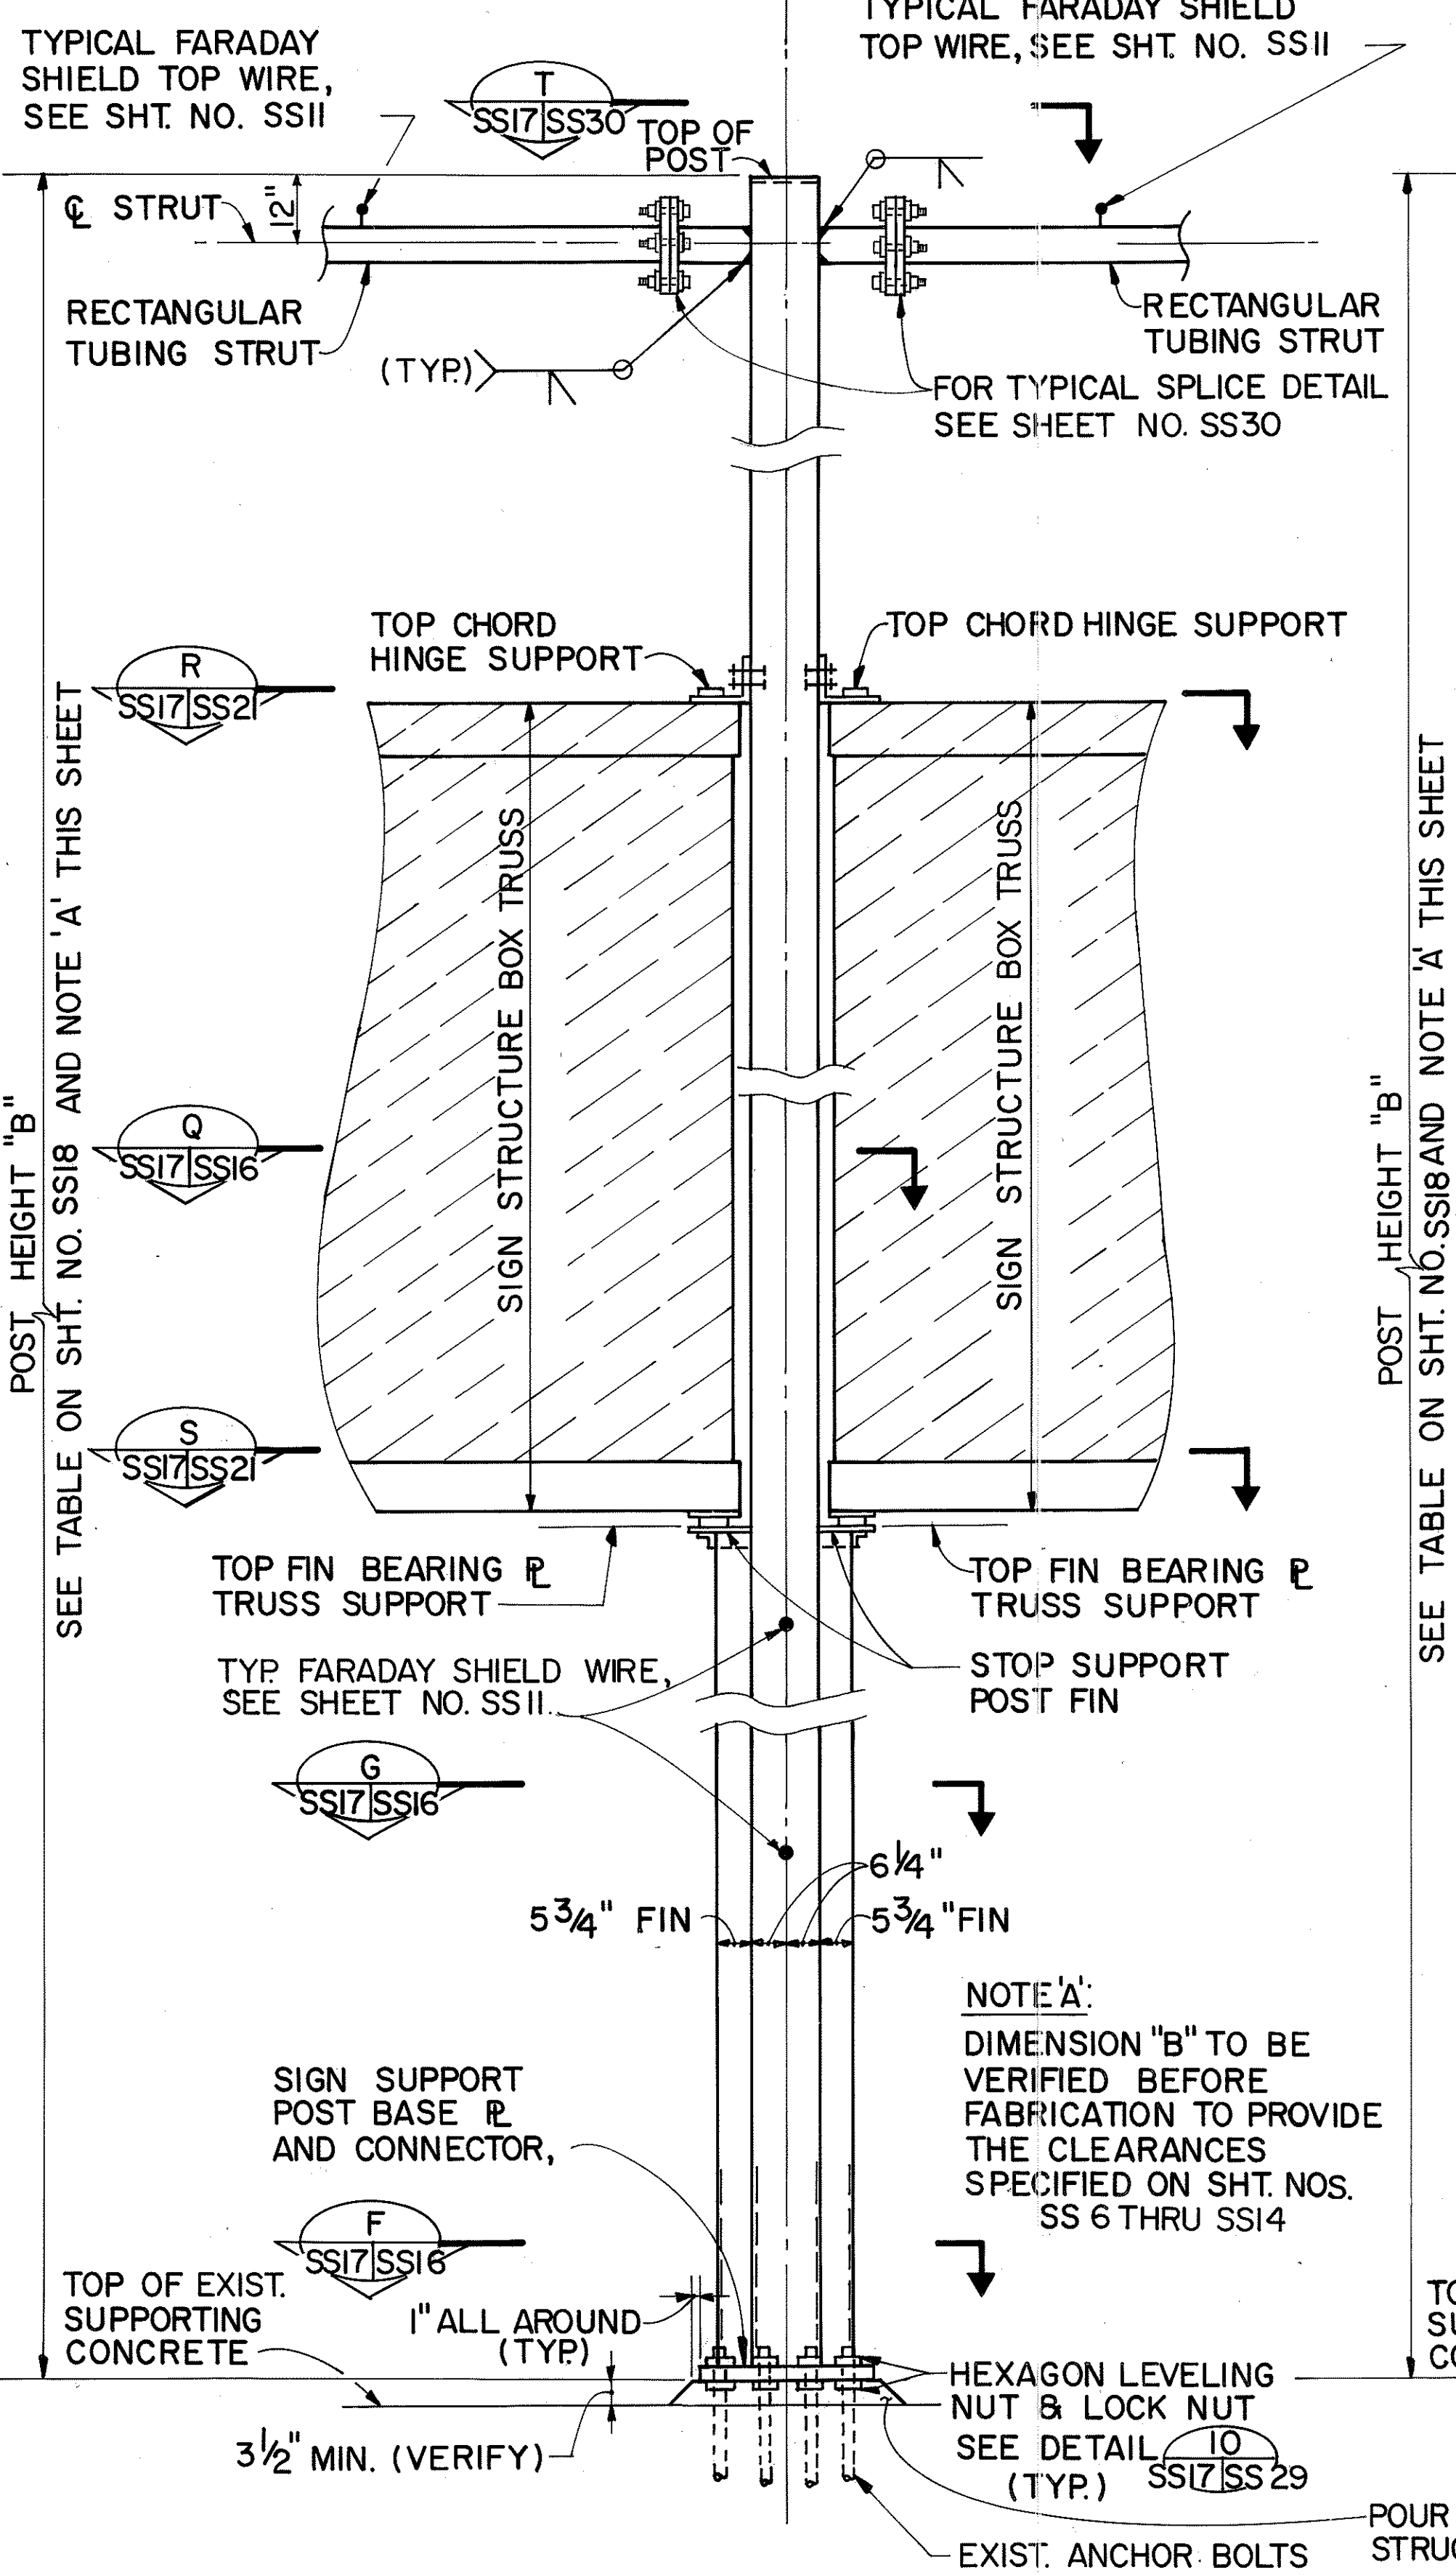


ELEVATION FOR POST B
SCALE: 1/2" = 1'-0"

SPAN-SEE TABLE ON SHT. NO. SS18

POST

SPAN-SEE TABLE ON SHT. NO. SS18

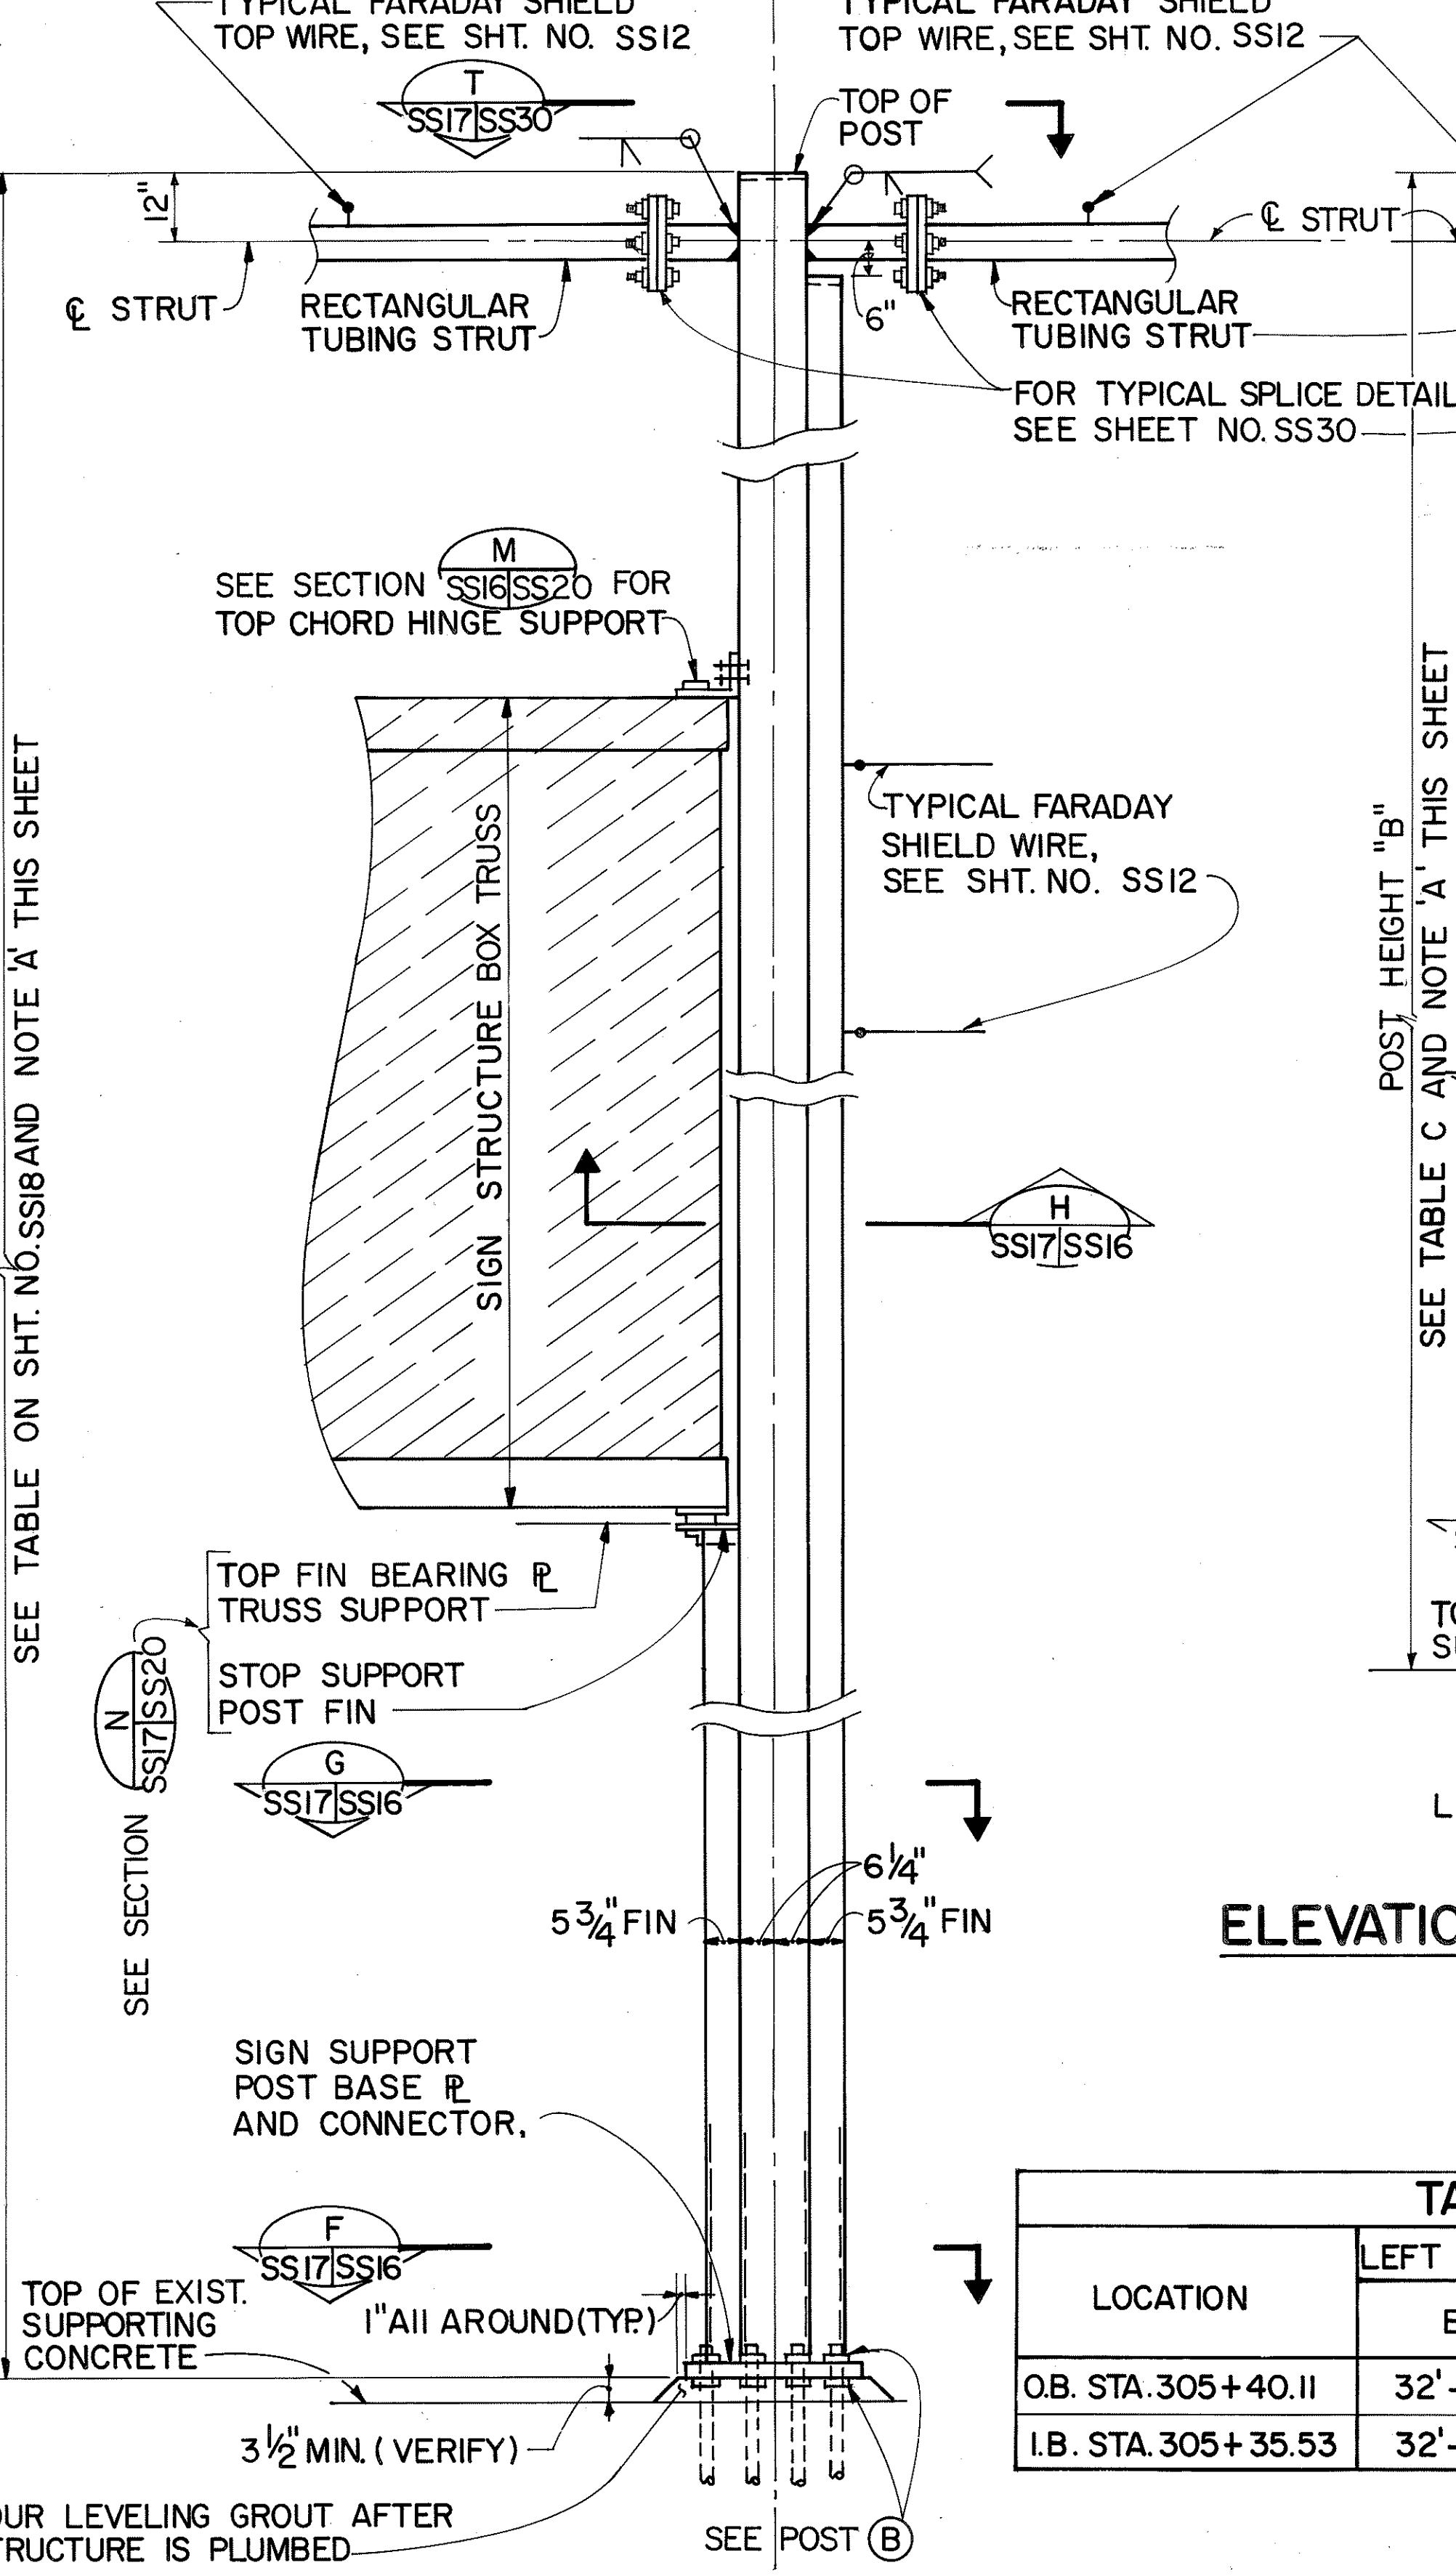


ELEVATION FOR POST G
SCALE: 1/2" = 1'-0"

SPAN-SEE TABLE ON SHT. NO. SS18

POST

SPAN-SEE TABLE ON SHT. NO. SS18

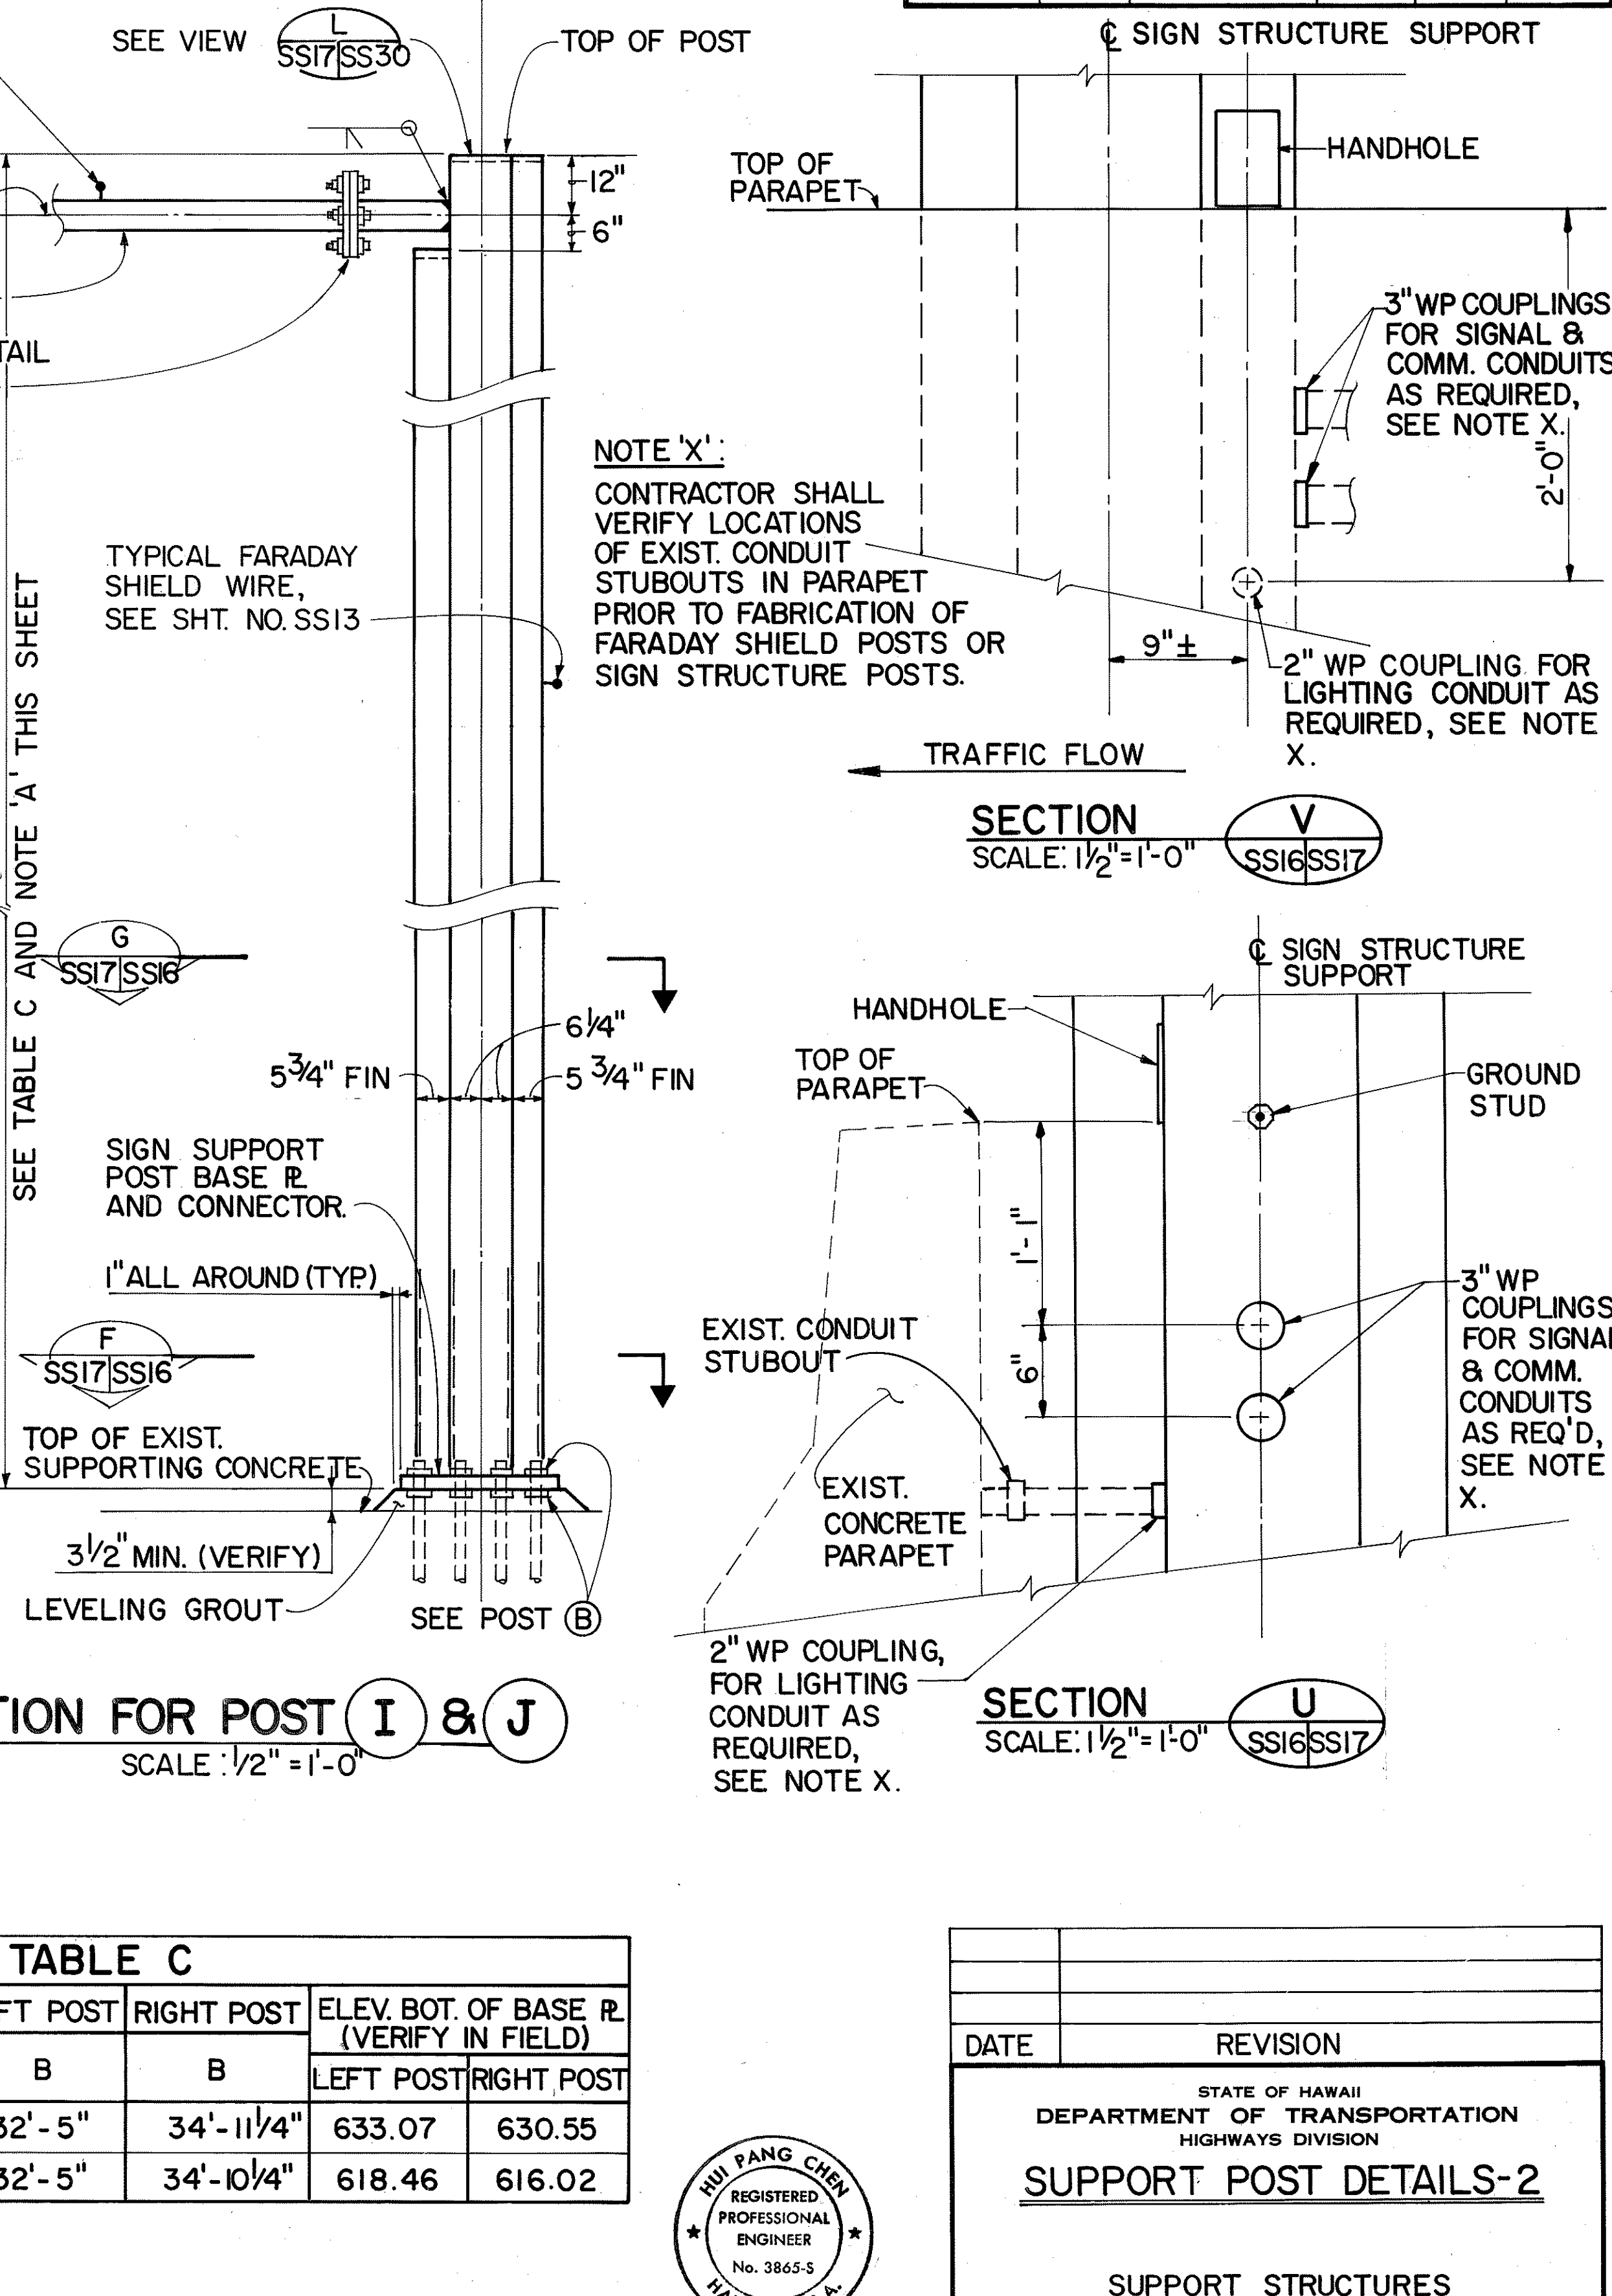

ELEVATION FOR POST I & J
SCALE: 1/2" = 1'-0"


TABLE C

LOCATION	LEFT POST	RIGHT POST	ELEV. BOT. OF BASE R. (VERIFY IN FIELD)	
	B	B	LEFT POST	RIGHT POST
O.B. STA. 305+40.11	32'-5"	34'-11 1/4"	633.07	630.55
I.B. STA. 305+35.53	32'-5"	34'-10 1/4"	618.46	616.02





THIS WORK WAS PREPARED BY ME OR UNDER MY SUPERVISION.

Hui Pang Chen

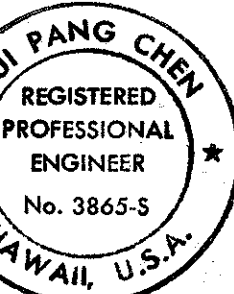

NOTE 'X':
CONTRACTOR SHALL VERIFY LOCATIONS OF EXIST. CONDUIT STUBOUTS IN PARAPET PRIOR TO FABRICATION OF FARADAY SHIELD POSTS OR SIGN STRUCTURE POSTS.

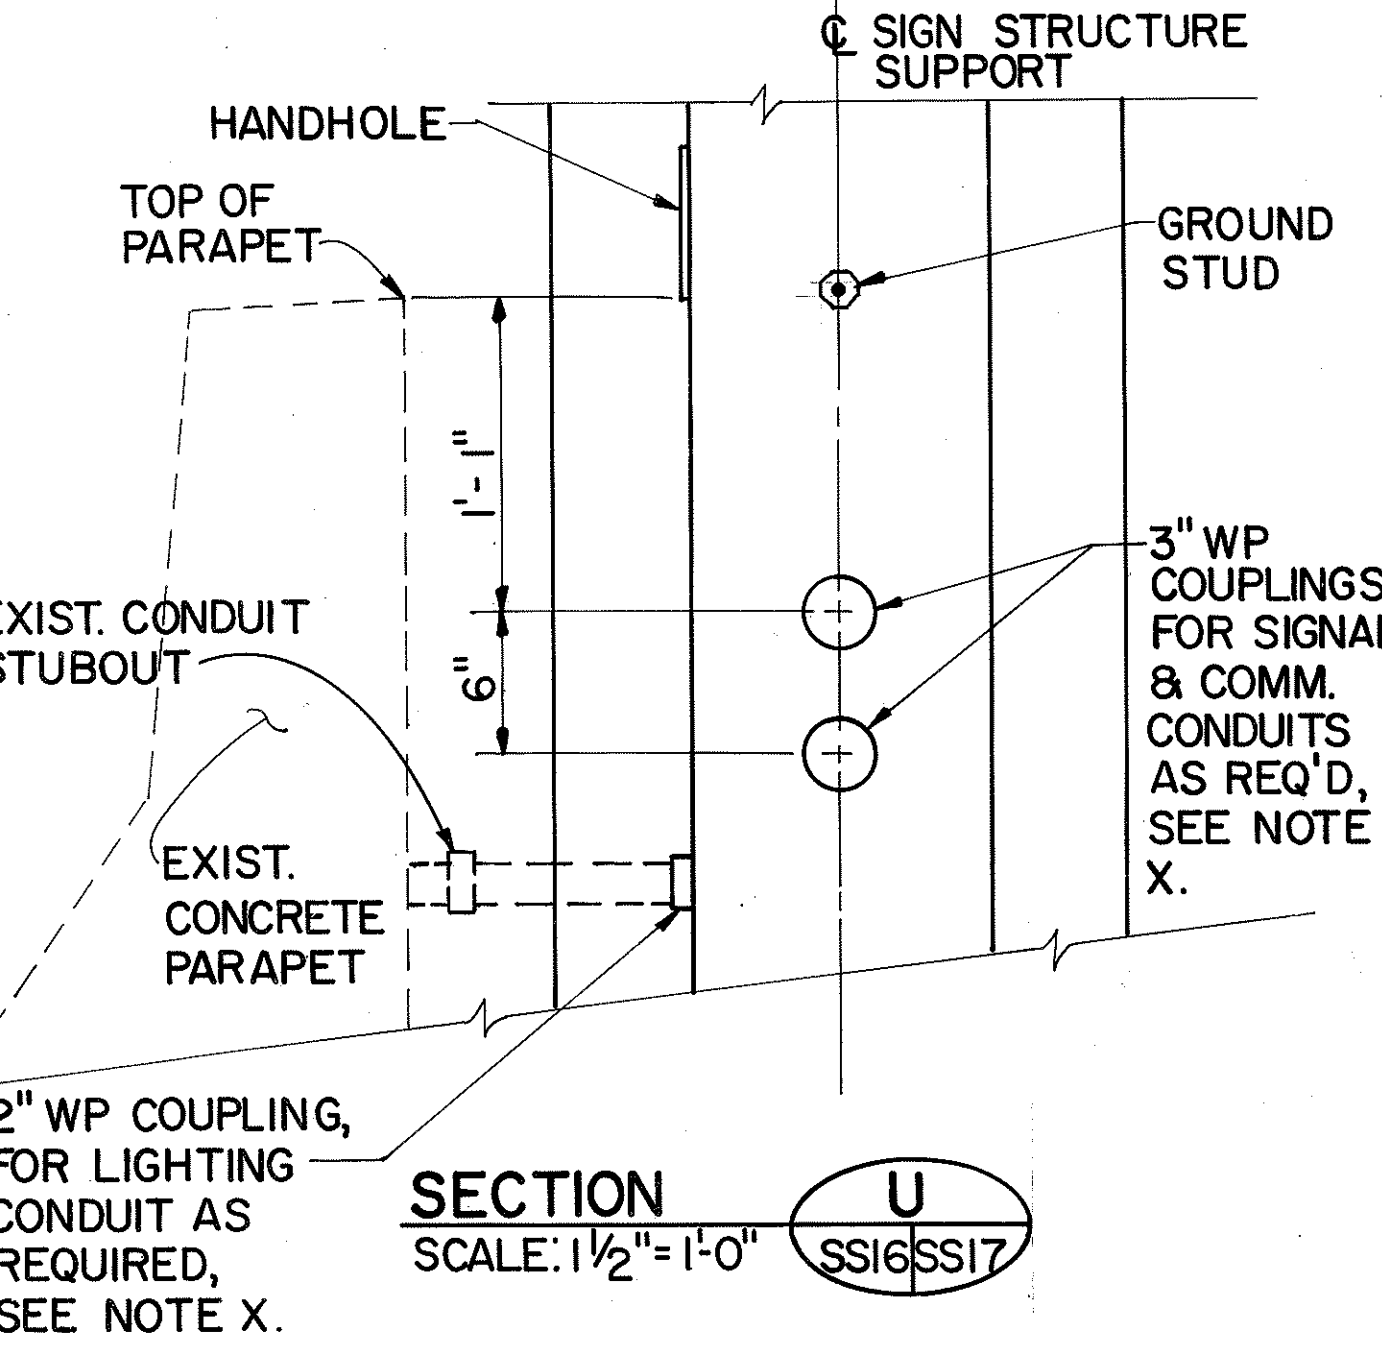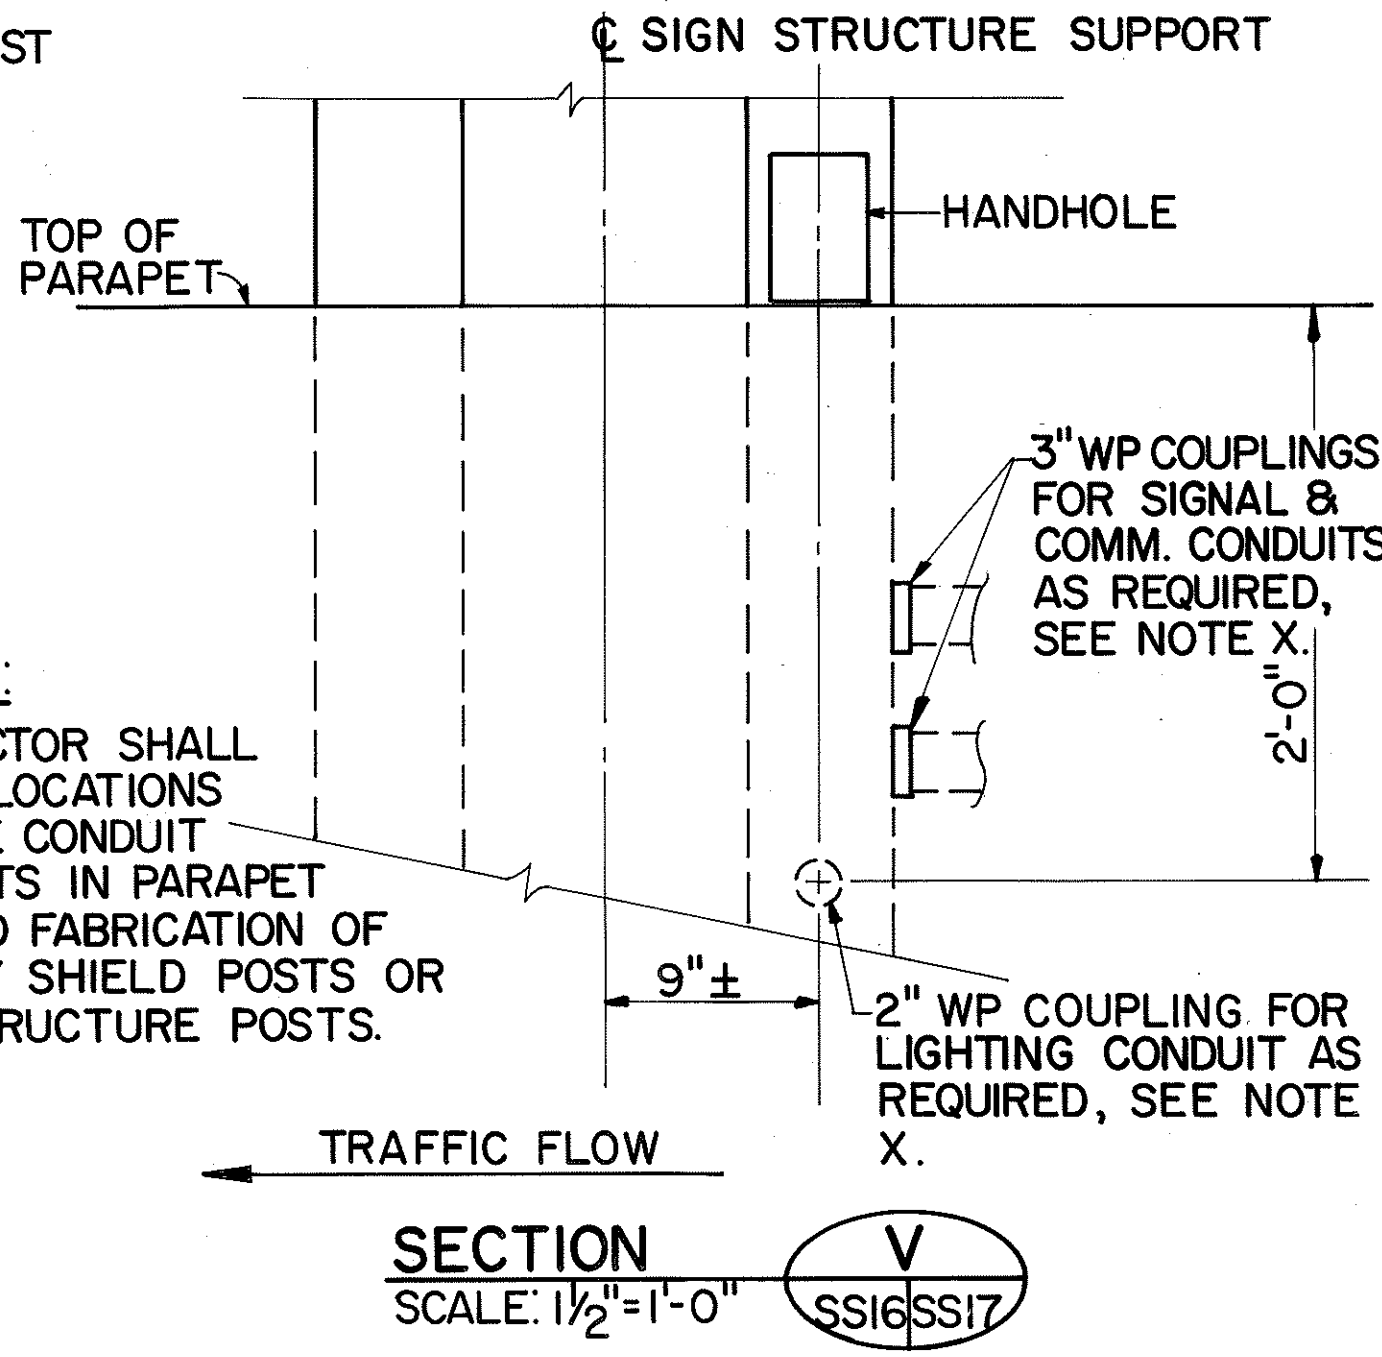

DATE	REVISION

STATE OF HAWAII
DEPARTMENT OF TRANSPORTATION
HIGHWAYS DIVISION


SUPPORT POST DETAILS-2

SUPPORT STRUCTURES
INTERSTATE ROUTE H-3
F.A.I. PROJ. NO. I-H3-1 (66)

SCALE: AS SHOWN DATE: APR. 1992
SHEET No. SS17 OF 36 SHEETS

ORIGINAL PLAN
DATE: 1/92
DESIGNED BY: K. WADA
CHECKED BY: S. CHEN


FED. ROAD DIST. NO.	STATE	FED. AID PROJ. NO.	FISCAL YEAR	SHEET NO.	TOTAL SHEETS
HAWAII	HAW.	I-H3-1(66)	1992	380	440

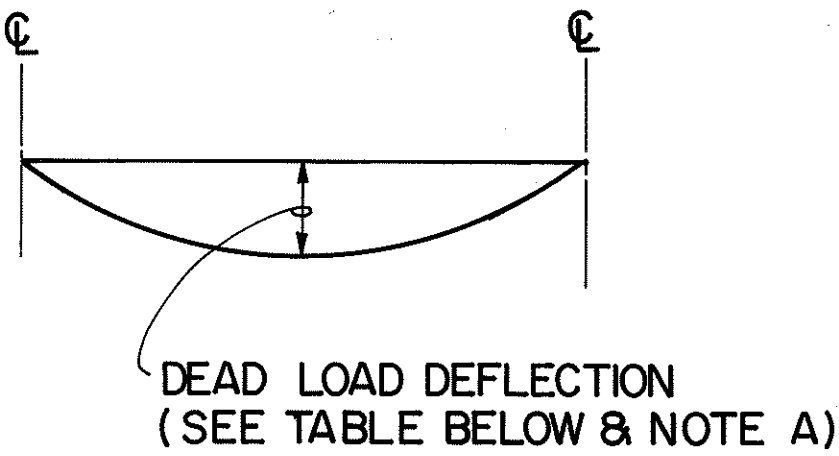

DEAD LOAD DEFLECTION

N.T.S.


NOTE 'A':
THE DEAD LOAD DEFLECTION INCLUDES THE EFFECT OF THE WEIGHT OF THE TRUSS. A CAMBER SHALL BE PROVIDED TO ACCOMMODATE THIS DEFLECTION.

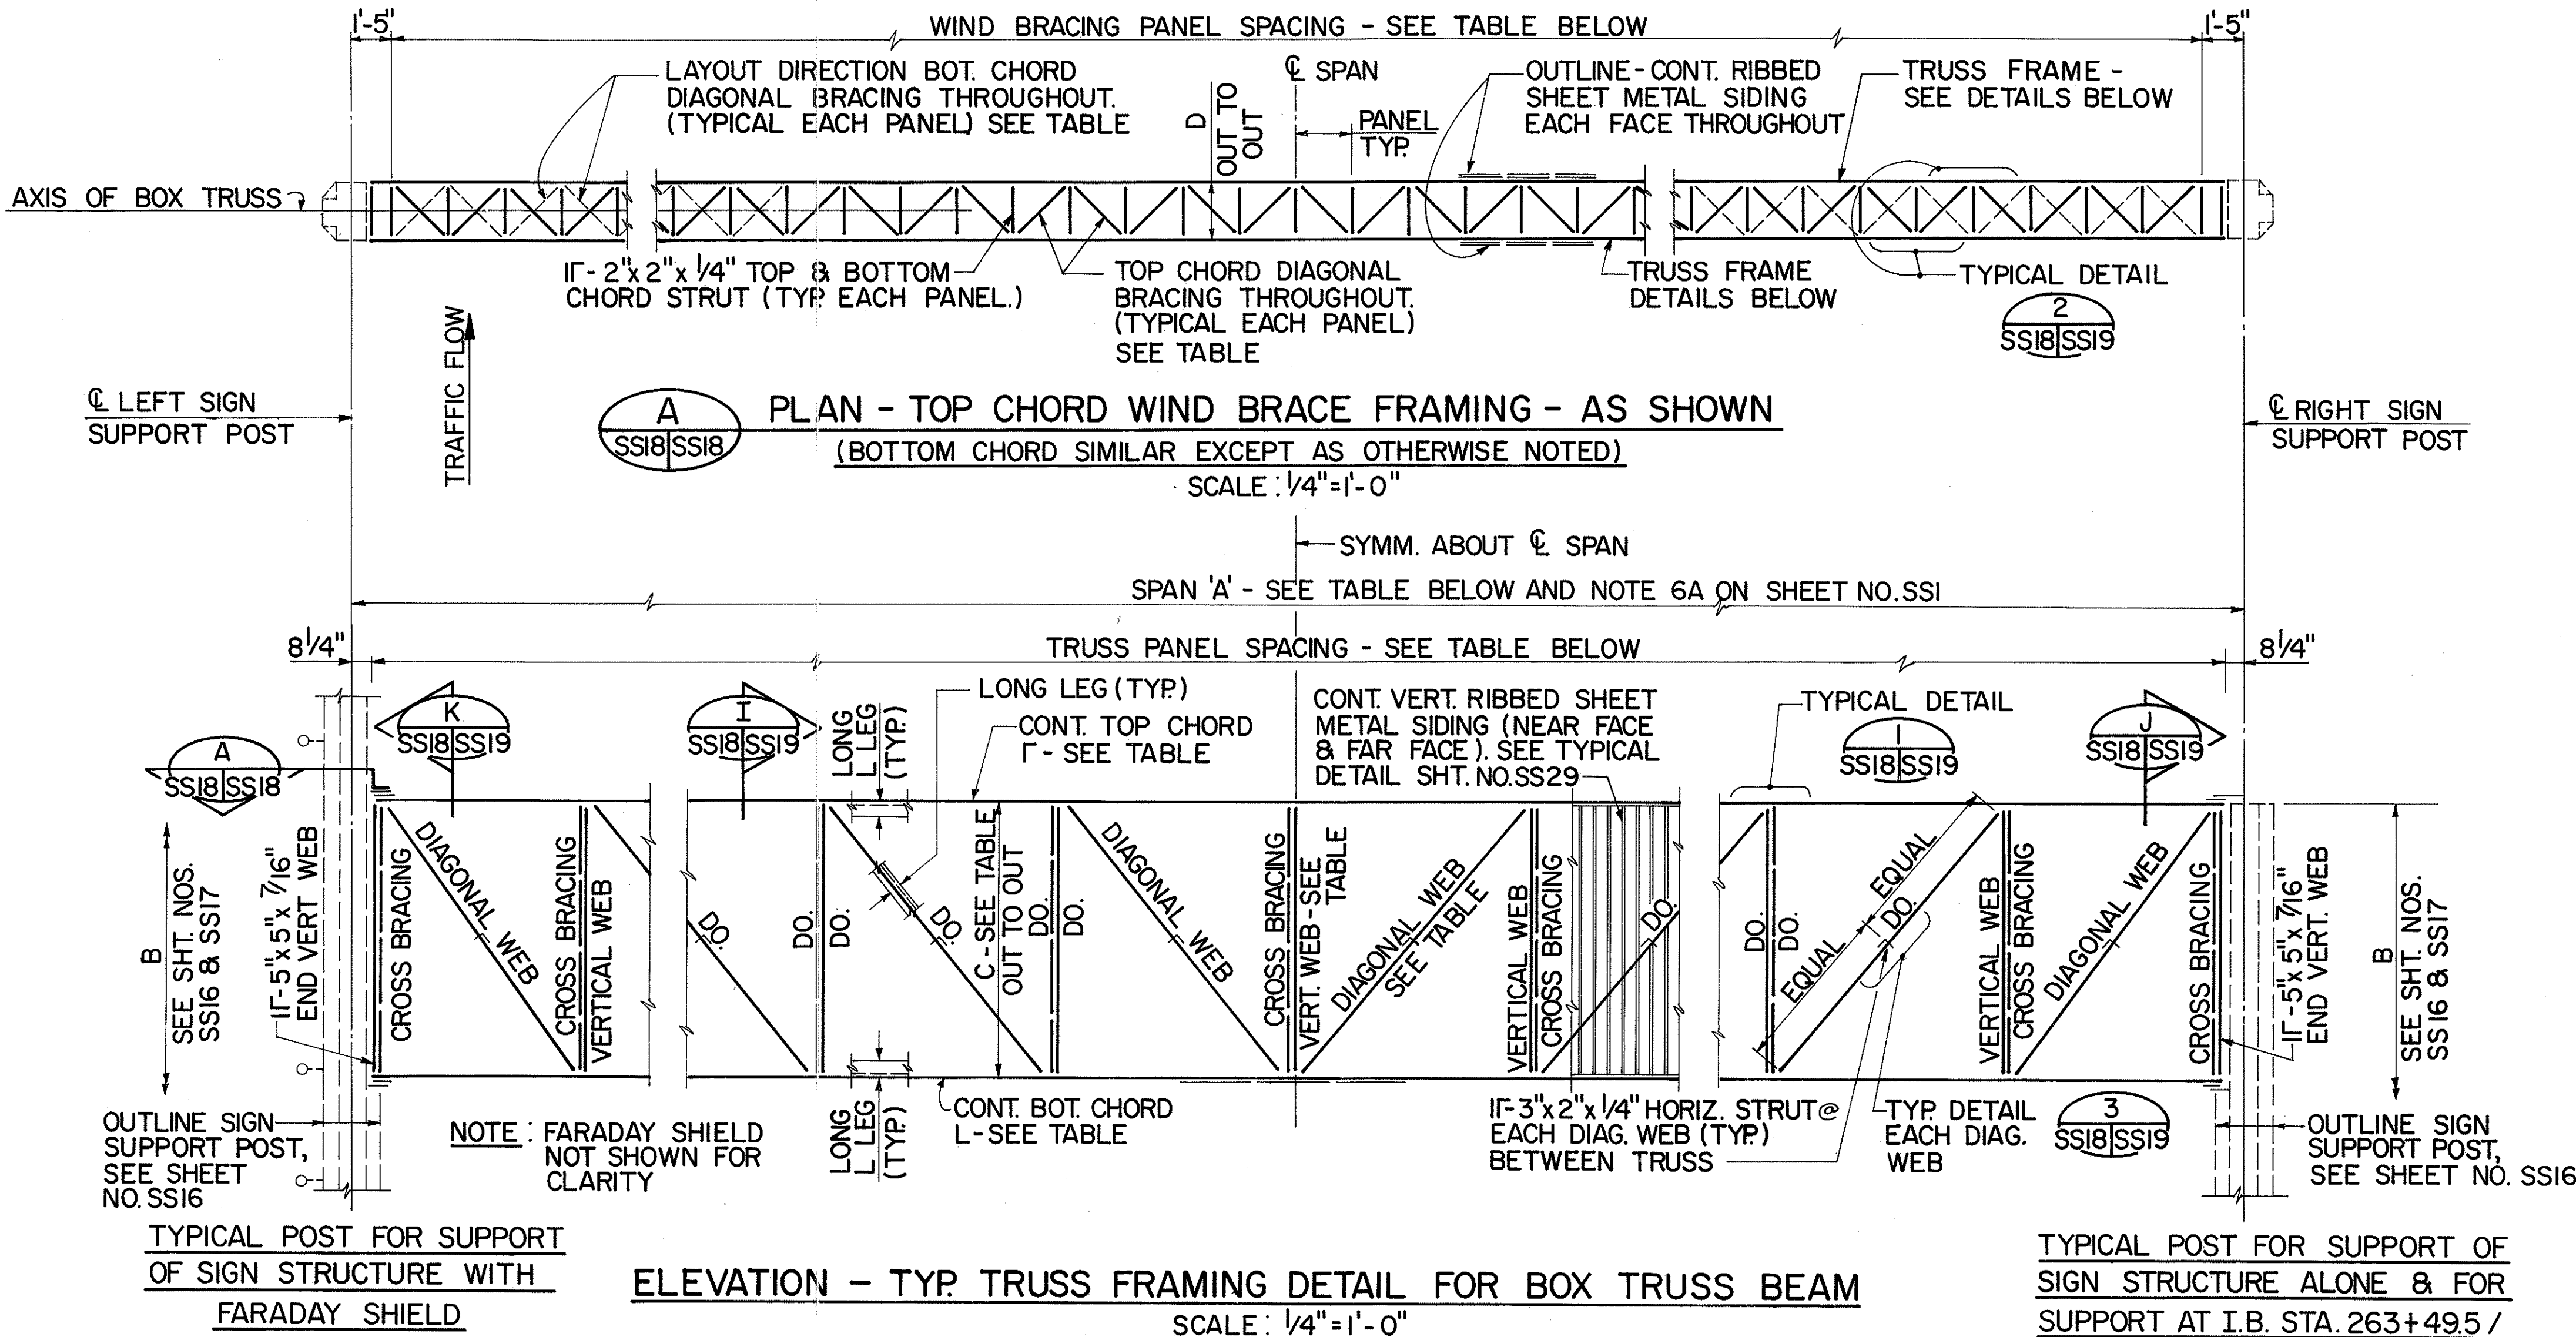

* NOTE: FOR ADDITIONAL DETAILS FOR MID-SPAN SUPPORT AT O.B. STA. 262+41.99, SEE SHEET NO. SS34.
** CENTRAL POST B = 35'-1/4", SEE LAYOUT ON SHEET NO. SS11

	LOCATION	SPAN A	LEFT POST	RIGHT POST	TRUSS DEPTH	TRUSS WIDTH	TRUSS PANELS SPACING	TRUSS			WIND BRACING PANEL SPACING	DIAG. BRACING TOP & BOT. CHORDS	ELEV. BOT. OF BASE R. (VERIFY IN FIELD)		DEAD LOAD DEFLECTION
			B	B				TOP & BOT. CHORD SIZE	VERT. WEB SIZE	DIAG. WEB SIZE			LEFT POST	RIGHT POST	
H A I K U	I.B. STA. 262+58.75	71'-10"±	32'-5"	**	8'-0"	2'-6"	10 EQUAL PANELS @ 7'-0 1/2"± = 70'-5"±	25x3 1/2x5/8	23 1/2x3 1/2x5/16	24x3 1/2x5/16	28 EQUAL PANELS @ 2'-5 7/16"± = 69'-0"±	2x2x5/16	816.90	814.21	1/8"
	* O.B. STA. 262+41.99	103'-2 3/8"±	**	32'-1 1/16"	8'-0"	2'-6"	16 EQUAL PANELS @ 6'-43/8"± = 101'-10"±	26x4x3/4	23 1/2x3 1/2x5/16	24x3 1/2x5/16	42 EQUAL PANELS @ 2'-4 1/16"± = 100'-4 7/8"±	2x2x2 1/2x3/8	814.21	817.23	3/8"
	I.B. STA. 263+49.50 / O.B. STA. 263+28.50	163'-3 3/8"±	32'-5"	31'-11 1/2"	5'-0"	3'-0"	38 EQUAL PANELS @ 4'-3 3/8"± = 161'-10 3/4"±	28x6x1	23 1/2x3 1/2x5/16	24x3 1/2x5/16	54 EQUAL PANELS @ 2'-11 5/8"± = 160'-3 3/4"±	2x2x2 1/2x3/8	813.08	813.55	3/4"
	I.B. STA. 264+49.10	60'-5 1/8"±	32'-5"	33'-7 7/8"	8'-0"	2'-0"	8 EQUAL PANELS @ 7'-4 9/16"± = 59'-0 1/2"±	25x3 1/2x5/8	23 1/2x3 1/2x5/16	24x3 1/2x5/16	28 EQUAL PANELS @ 2'-0 1/16"± = 57'-7 1/4"±	2x2x1/4	808.85	807.61	1/16"
	O.B. STA. 273+70.11	50'-0"	35'-3 1/2"	32'-5"	10'-0"	2'-0"	6 EQUAL PANELS @ 8'-1 1/4"± = 48'-7 1/2"±	25x3 1/2x5/8	23 1/2x3 1/2x5/16	24x3 1/2x5/16	24 EQUAL PANELS @ 1'-11 9/16"± = 47'-1 1/2"±	2x2x5/16	766.98	769.86	1/16"
	I.B. STA. 279+45.53	44'-0"	34'-11 9/16"	32'-5"	8'-0"	2'-0"	6 EQUAL PANELS @ 7'-1 1/4"± = 42'-7 1/2"±	25x3 1/2x3/8	23 1/2x3 1/2x5/16	24x3 1/2x5/16	22 EQUAL PANELS @ 1'-10 7/16"± = 41'-1 5/8"±	2x2x1/4	743.36	745.91	1/16"
	I.B. STA. 287+85.53	44'-0"	34'-10 3/4"	32'-5"	6'-0"	2'-0"	8 EQUAL PANELS @ 5'-3 5/16"± = 42'-7 1/2"±	25x3 1/2x3/8	23 1/2x3 1/2x5/16	24x3 1/2x5/16	22 EQUAL PANELS @ 1'-10 7/16"± = 41'-1 5/8"±	2x2x1/4	706.61	709.09	1/16"
H A L A W A	O.B. STA. 310+85.11	44'-0"	27'-0"	29'-6 1/4"	10'-0"	2'-0"	6 EQUAL PANELS @ 7'-1 1/4"± = 42'-7 1/2"±	25x3 1/2x3/8	23 1/2x3 1/2x5/16	24x3 1/2x5/16	22 EQUAL PANELS @ 1'-10 7/16"± = 41'-1 5/8"±	2x2x1/4	603.27	600.75	1/16"
	O.B. STA. 573+40	44'-0"	26'-5"	27'-2 1/8"	6'-0"	2'-0"	8 EQUAL PANELS @ 5'-3 5/16"± = 42'-7 1/2"±	25x3 1/2x3/8	23 1/2x3 1/2x5/16	24x3 1/2x5/16	22 EQUAL PANELS @ 1'-10 7/16"± = 41'-1 5/8"±	2x2x1/4	854.88	854.12	1/16"
	O.B. STA. 577+80	44'-0"	28'-5"	29'-2 1/8"	8'-0"	2'-0"	6 EQUAL PANELS @ 7'-1 1/4"± = 42'-7 1/2"±	25x3 1/2x3/8	23 1/2x3 1/2x5/16	24x3 1/2x5/16	22 EQUAL PANELS @ 1'-10 7/16"± = 41'-1 5/8"±	2x2x1/4	888.48	887.72	1/16"
	O.B. STA. 594+50	56'-4"	28'-5"	29'-2"	8'-0"	2'-0"	8 EQUAL PANELS @ 6'-10 1/16"± = 54'-11 1/2"±	25x3 1/2x5/8	23 1/2x3 1/2x5/16	24x3 1/2x5/16	26 EQUAL PANELS @ 2'-0 5/8"± = 53'-4 1/4"±	2x2x1/4	1001.29	1000.21	1/16"

ORIGINAL PLAN	DATE	1/92
DESIGNED BY	DATE	1/92
TRACED BY	DATE	1/92
NOTED BY	DATE	1/92
CHECKED BY	DATE	1/92

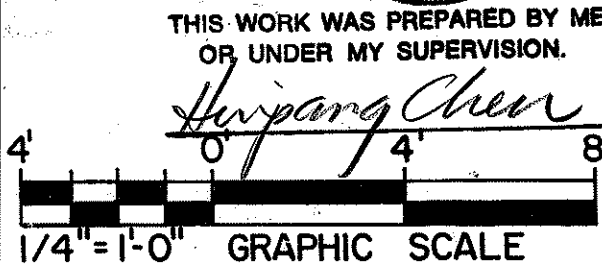

2/24/94

CLARIFY DIMENSIONS PER DCN 66-036

DATE

REVISION

STATE OF HAWAII

DEPARTMENT OF TRANSPORTATION

HIGHWAYS DIVISION

TRUSS FRAMING DETAILS

SUPPORT STRUCTURES

INTERSTATE ROUTE H-3

F.A.I. PROJ. NO. I-H3-1(66)

SCALE: AS SHOWN

DATE: APR. 1992

SHEET No. SS18 OF 36 SHEETS

HUI PANG CHEN

REGISTERED PROFESSIONAL ENGINEER


No. 3865-S

HAWAII, U.S.A.

THIS WORK WAS PREPARED BY ME OR UNDER MY SUPERVISION.


Hui Pang Chen

FED. ROAD DIST. NO.	STATE	FED. AID PROJ. NO.	FISCAL YEAR	SHEET NO.	TOTAL SHEETS
HAWAII	HAW.	I-H3-1(66)	1992	381	440

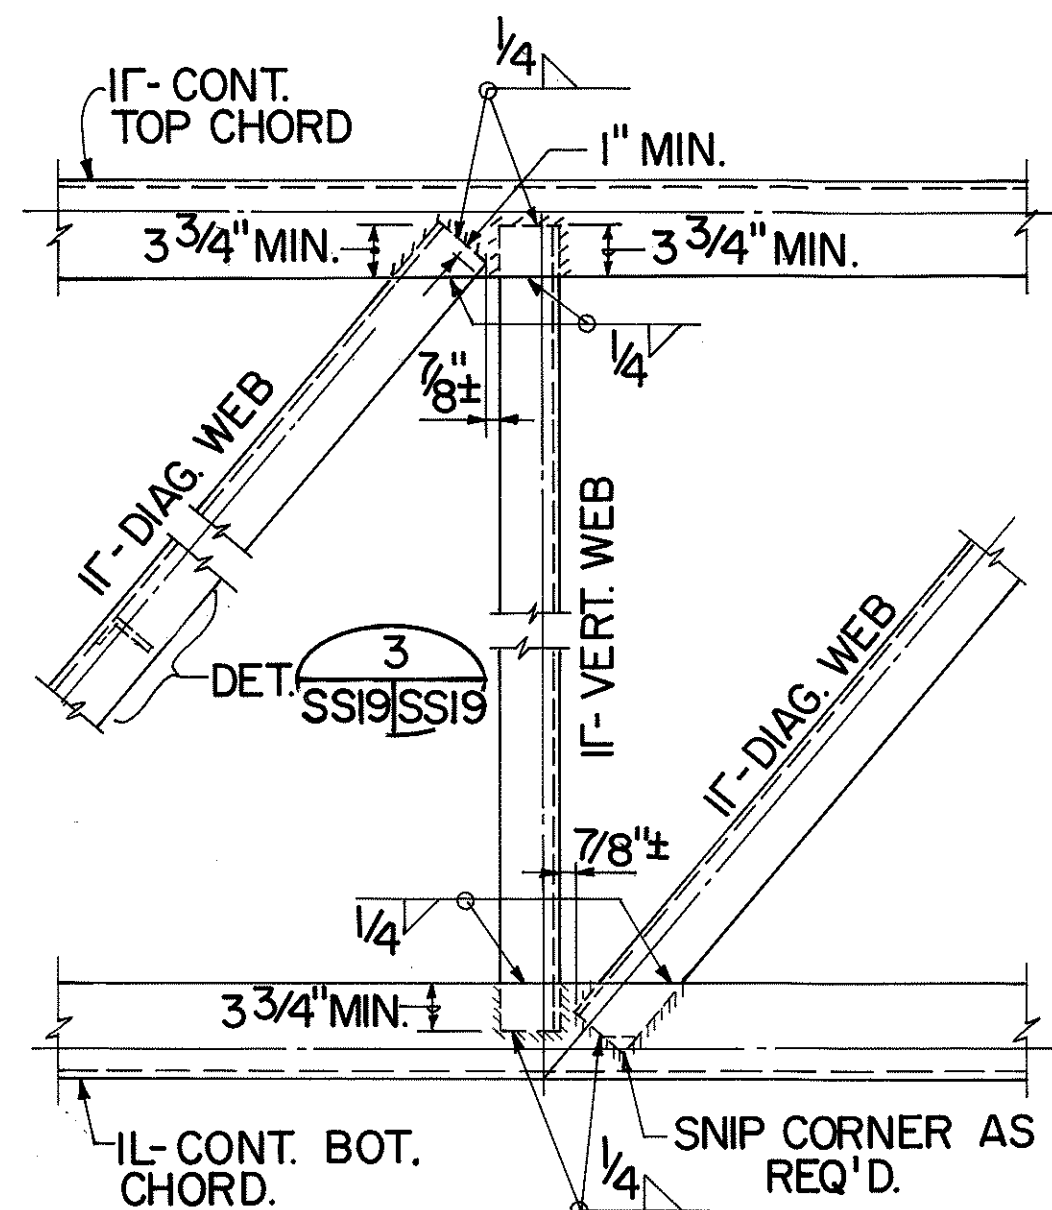


TYPICAL DETAIL 

SCALE: 1" = 1'-0" SS6, SS18 | SS19

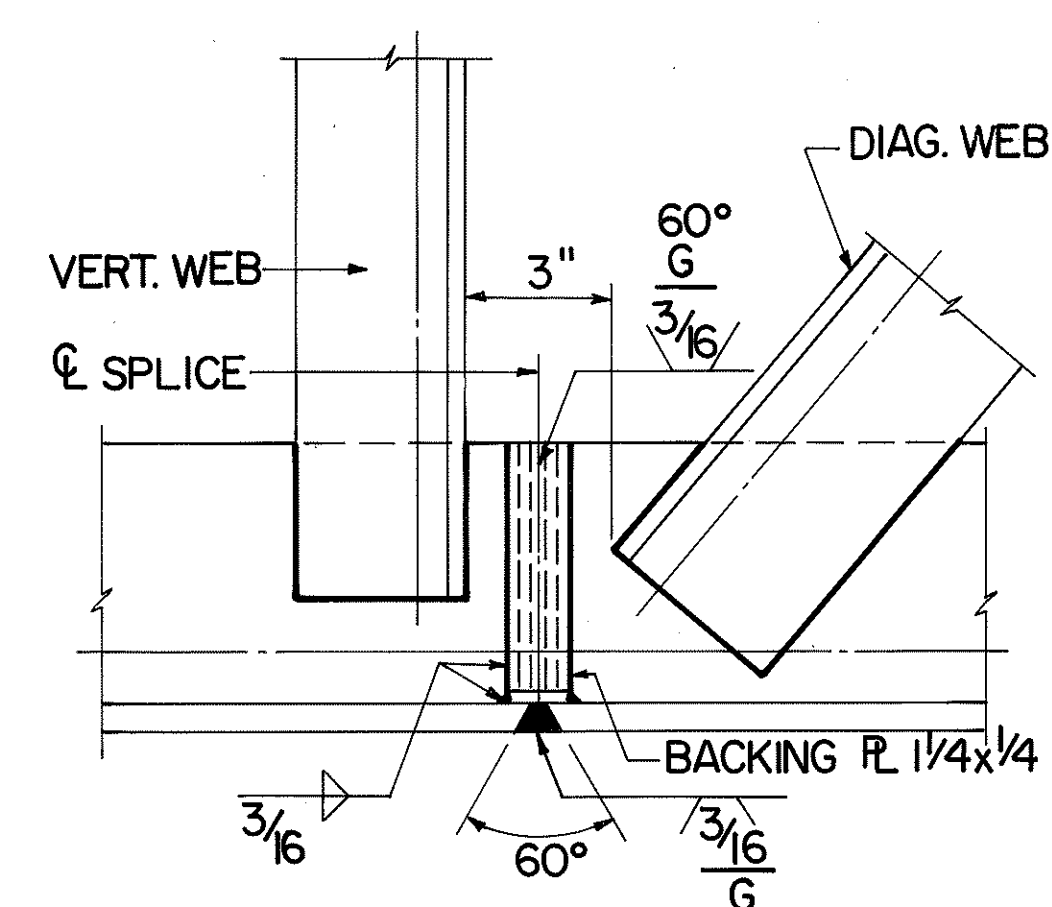


INTERIOR ELEVATION
TYPICAL TOP OR BOTTOM
TRUSS CHORD SHOP SPLICE DETAILS
SCALE : 3" = 1'-0"


NOTE: SHOP OR FIELD SPLICE LOCATIONS OF TOP & BOTTOM CHORDS AT EACH TRUSS SHALL BE STAGGERED & AT ALTERNATE LOCATIONS. INDICATE SPLICE LOCATIONS ON SHOP FABRICATION DRAWINGS FOR APPROVAL. IN NO CASE SHALL SPLICES BE LOCATED AT MIDSPAN OF TRUSS. THE SPLICE SHALL BE LOCATED SO AS NOT TO INTERFERE WITH THE MOUNTING OF THE WALKWAY BRACKETS.

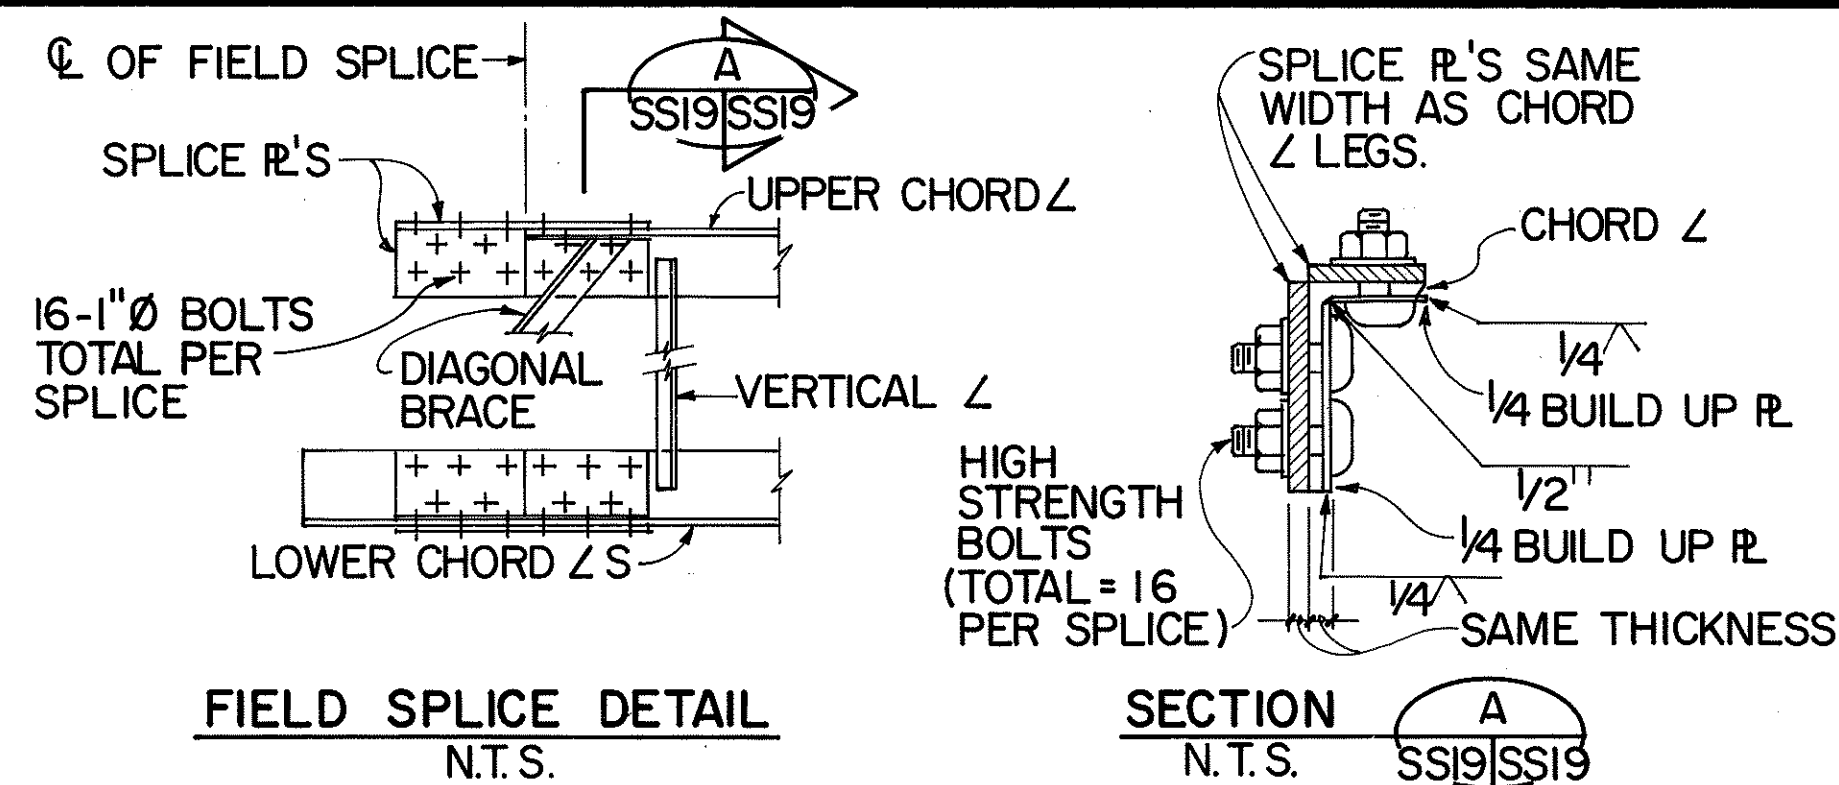

BUILD UP PLATE:
THE PLATES WILL
BE WELDED BEFORE
THE SAME LENGTH

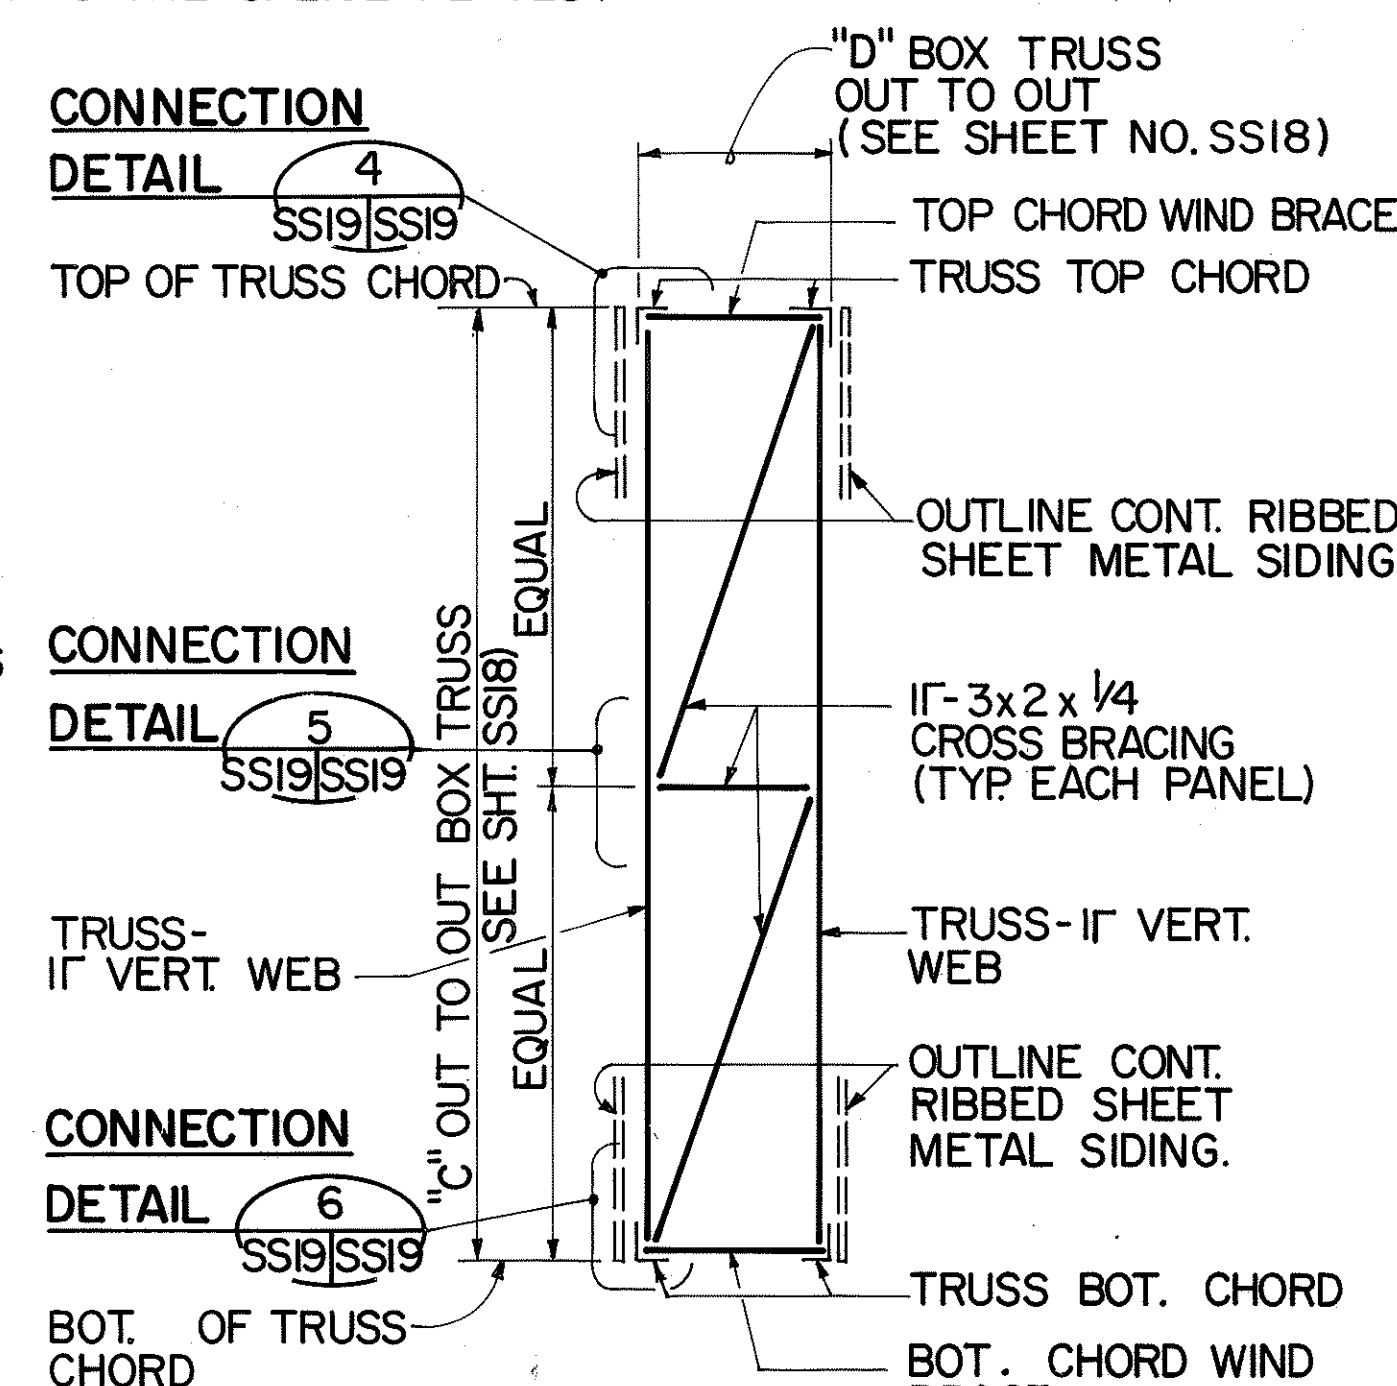


TYP. BOX TRUSS SECTION I
(INTERMEDIATE CROSS BRACING DETAILS) SS6 | SS19
SCALE: 1/2" = 1'-0" SS18

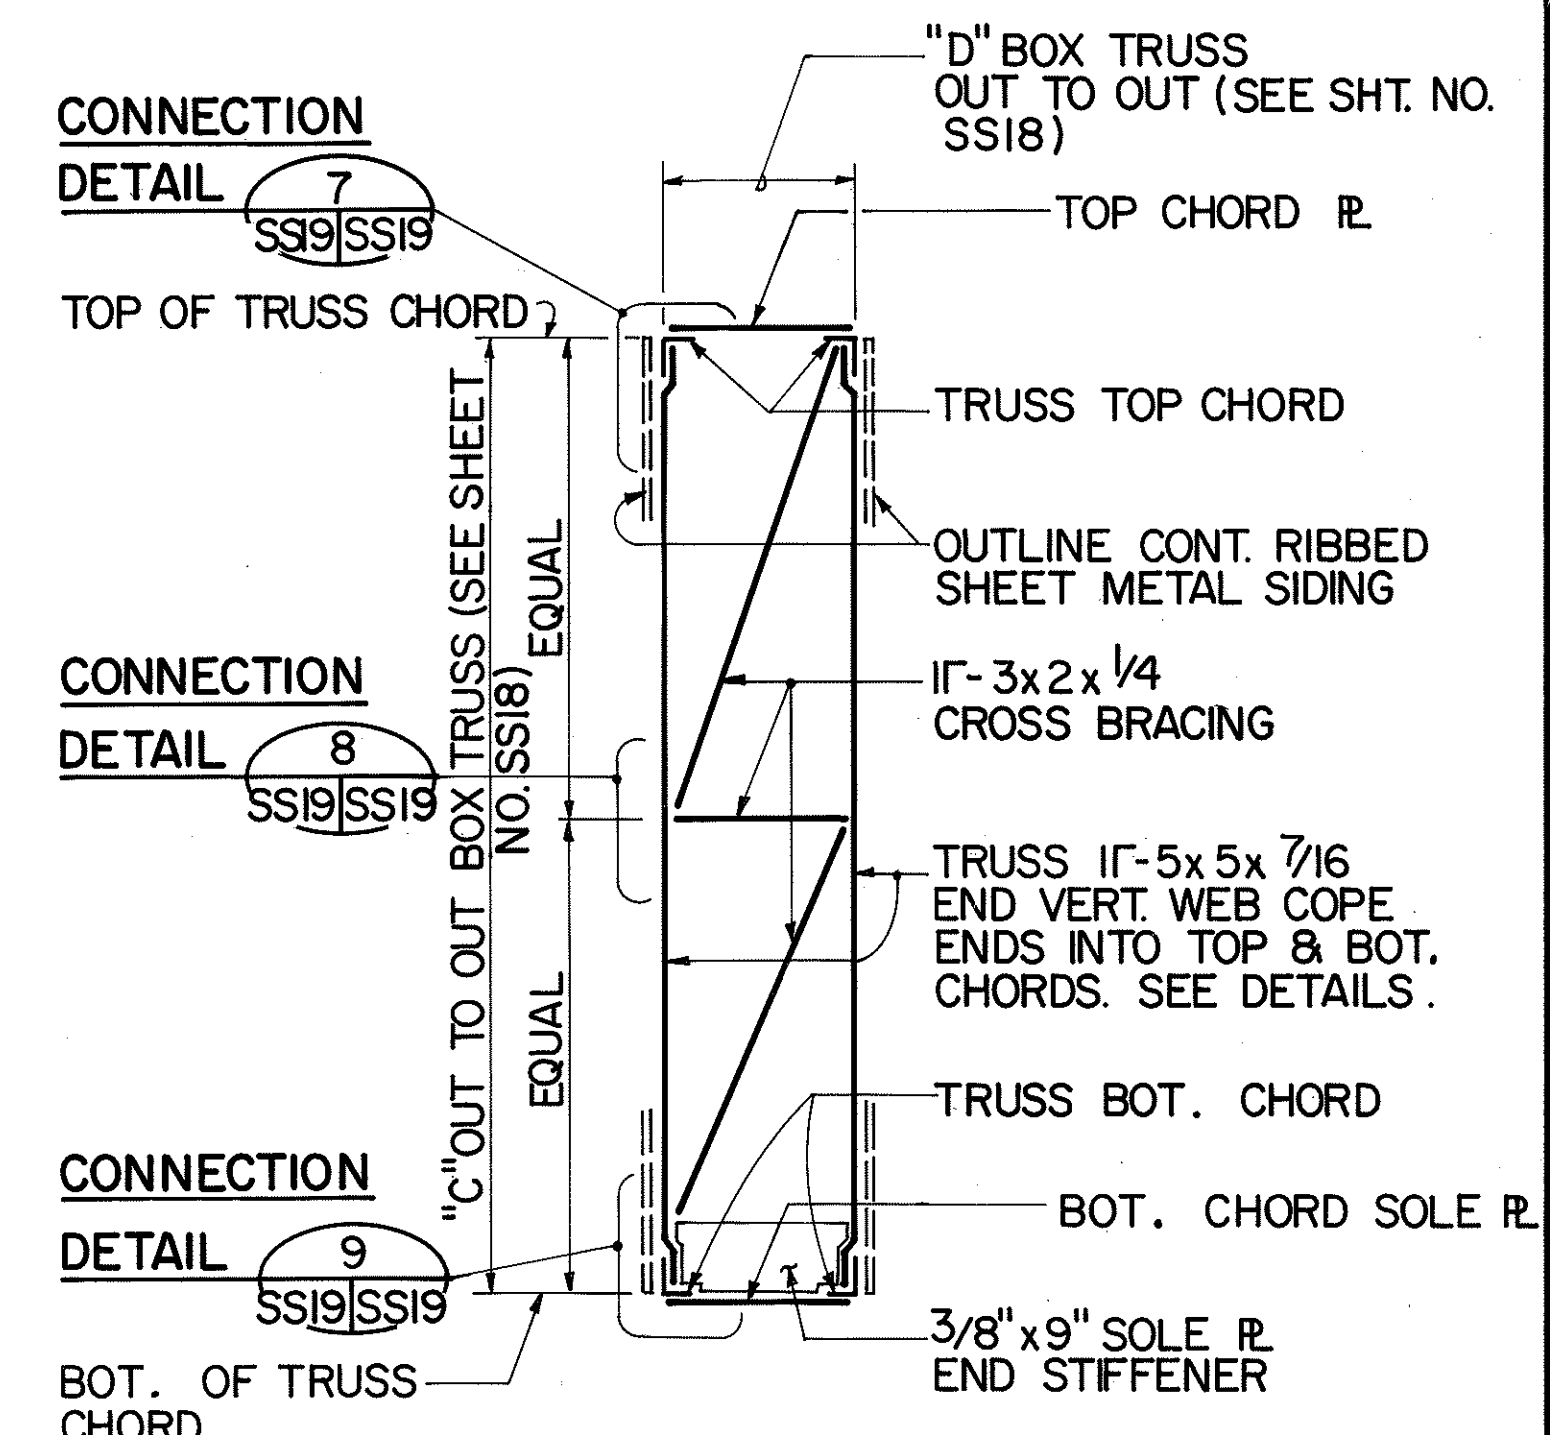


TYP. BOX TRUSS END SECTION J AS SHOWN
SS6,SS18|SS19


SECTION K SIMILAR EXCEPT OPPOSITE HAND
SS18|SS19 (END CROSS BRACING DETAILS)
SCALE : 1/2" = 1'-0"

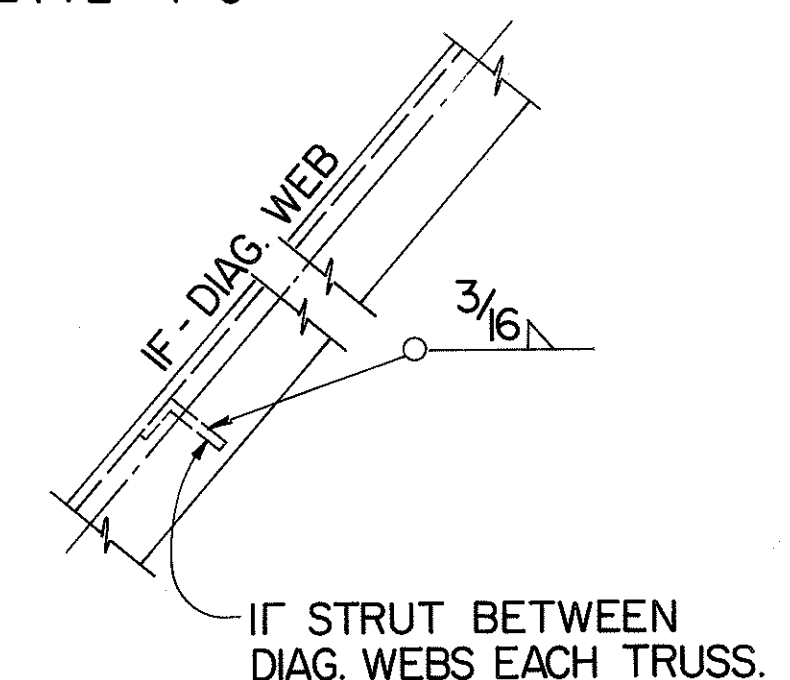

DETAIL 
N.T.S.

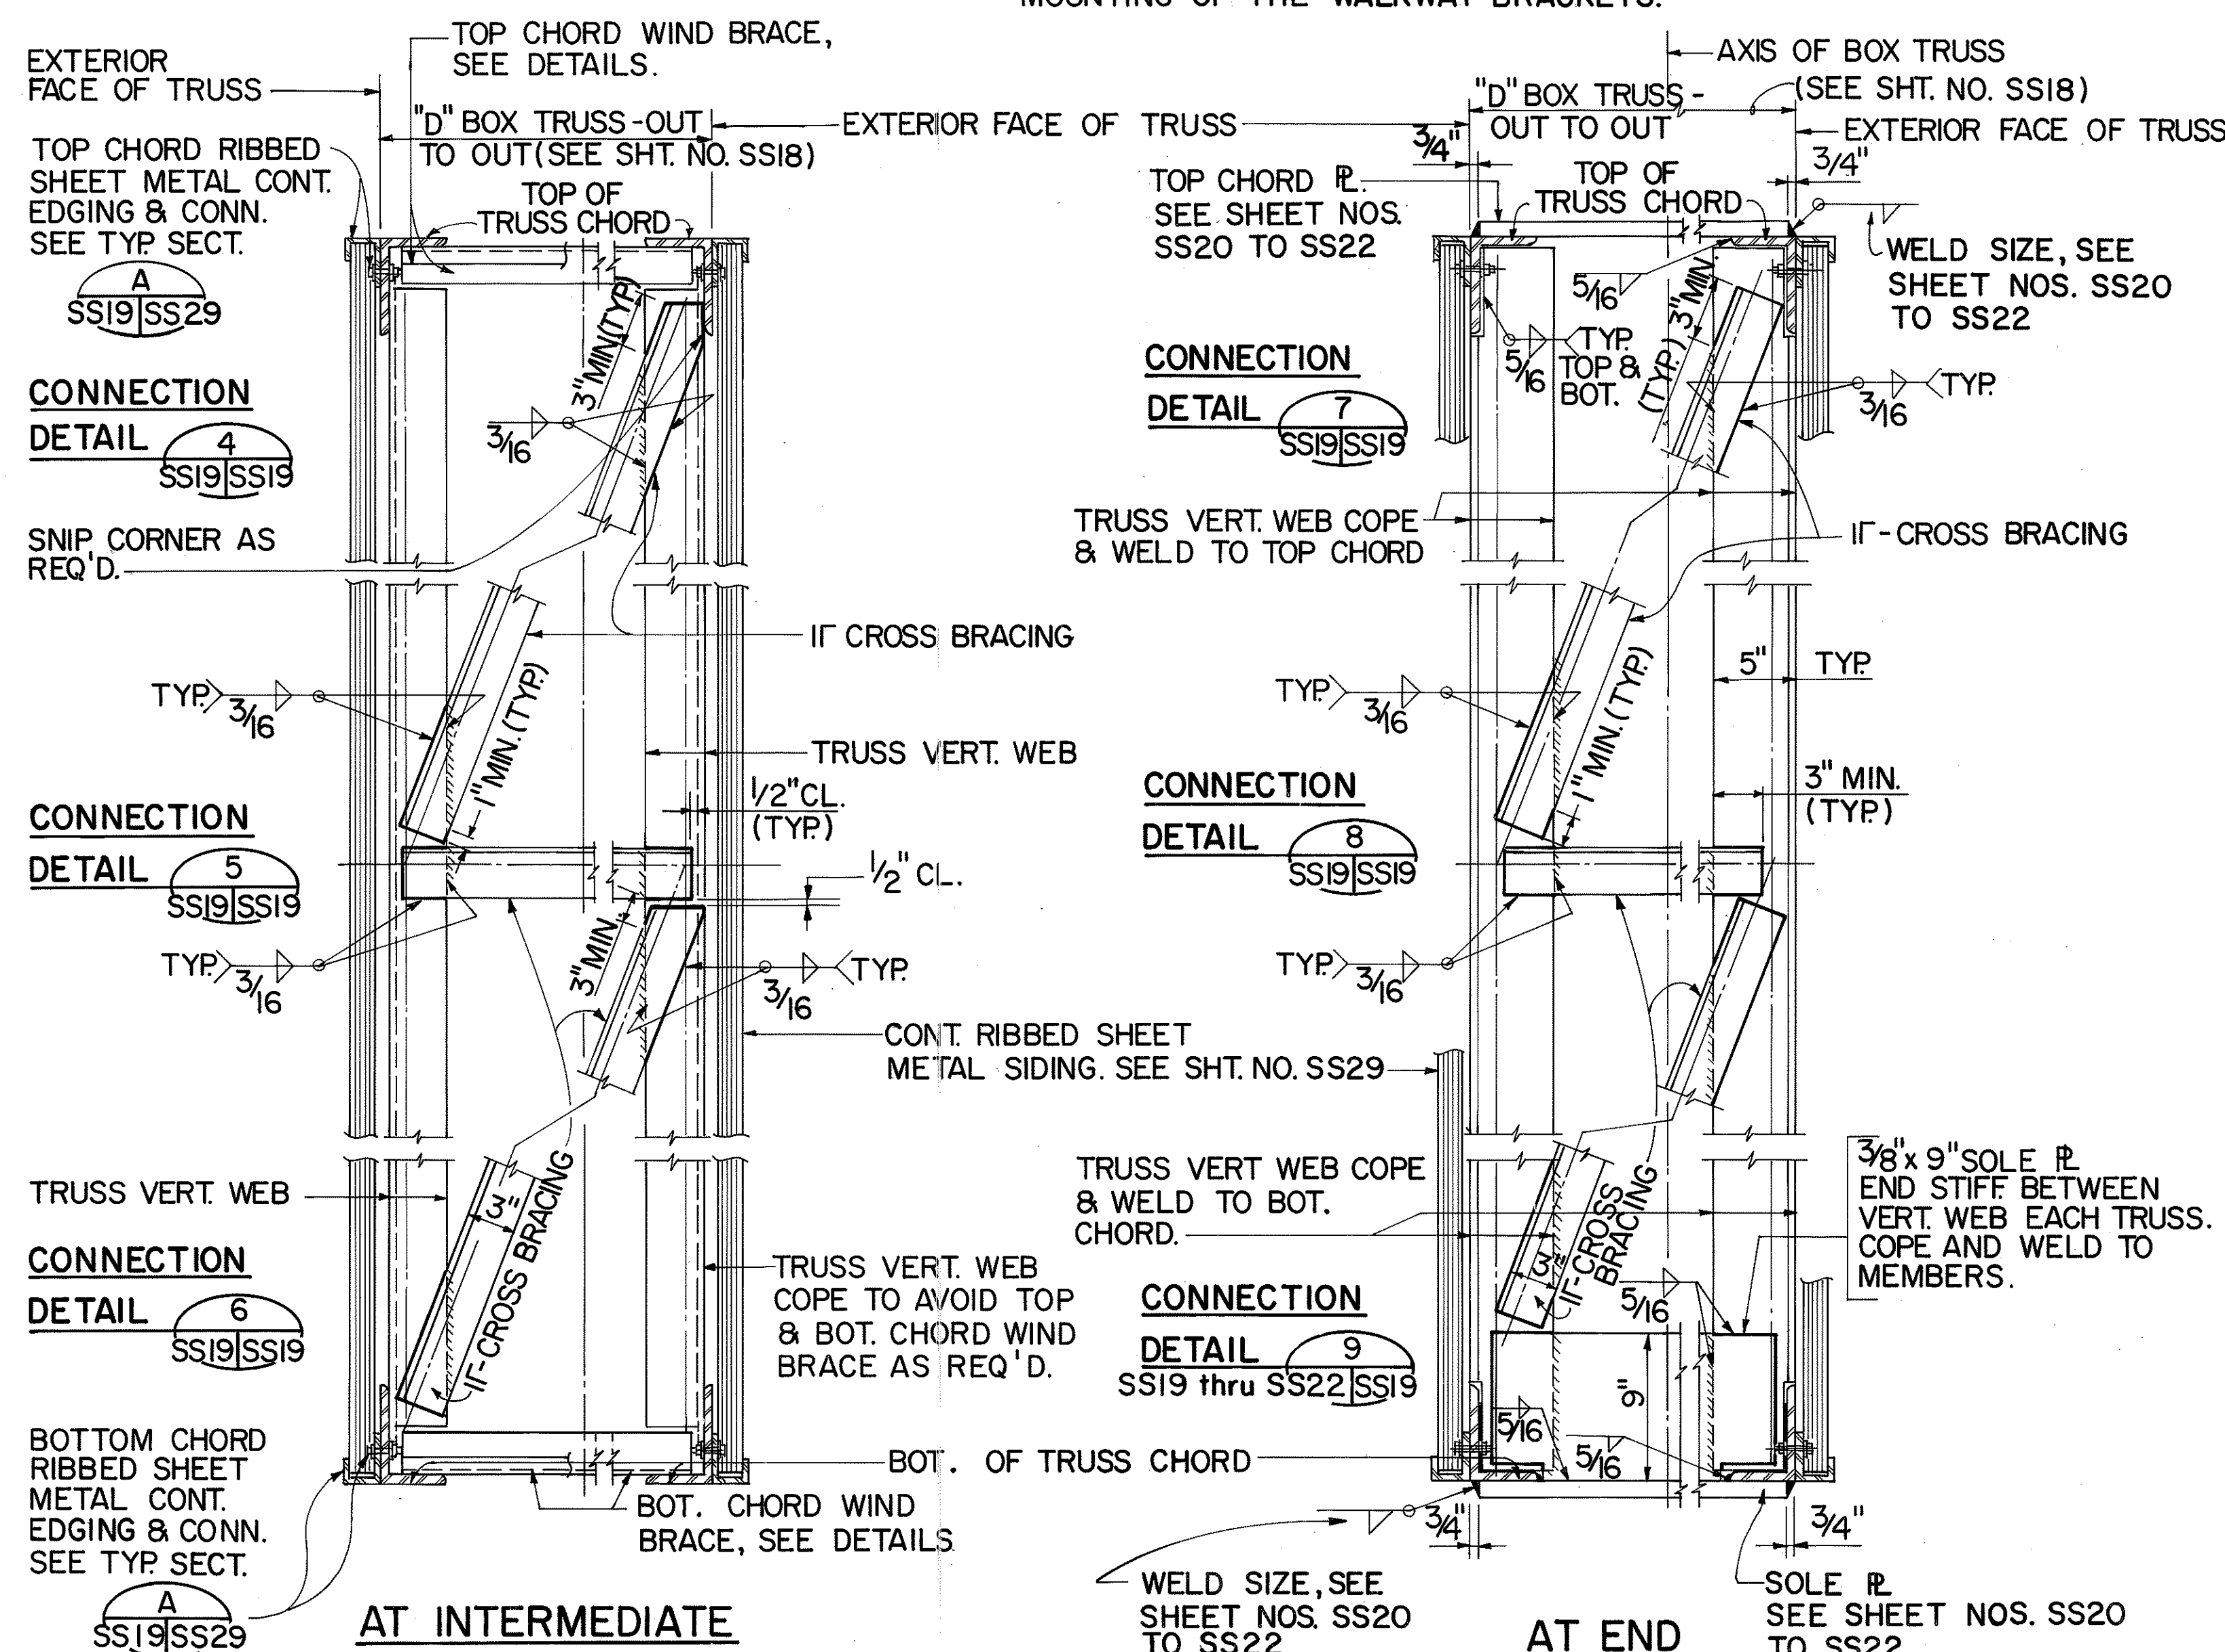

10 3522
TYPICAL BOX TRUSS DETAILS
SCALE: 1/2" = 1'-0"

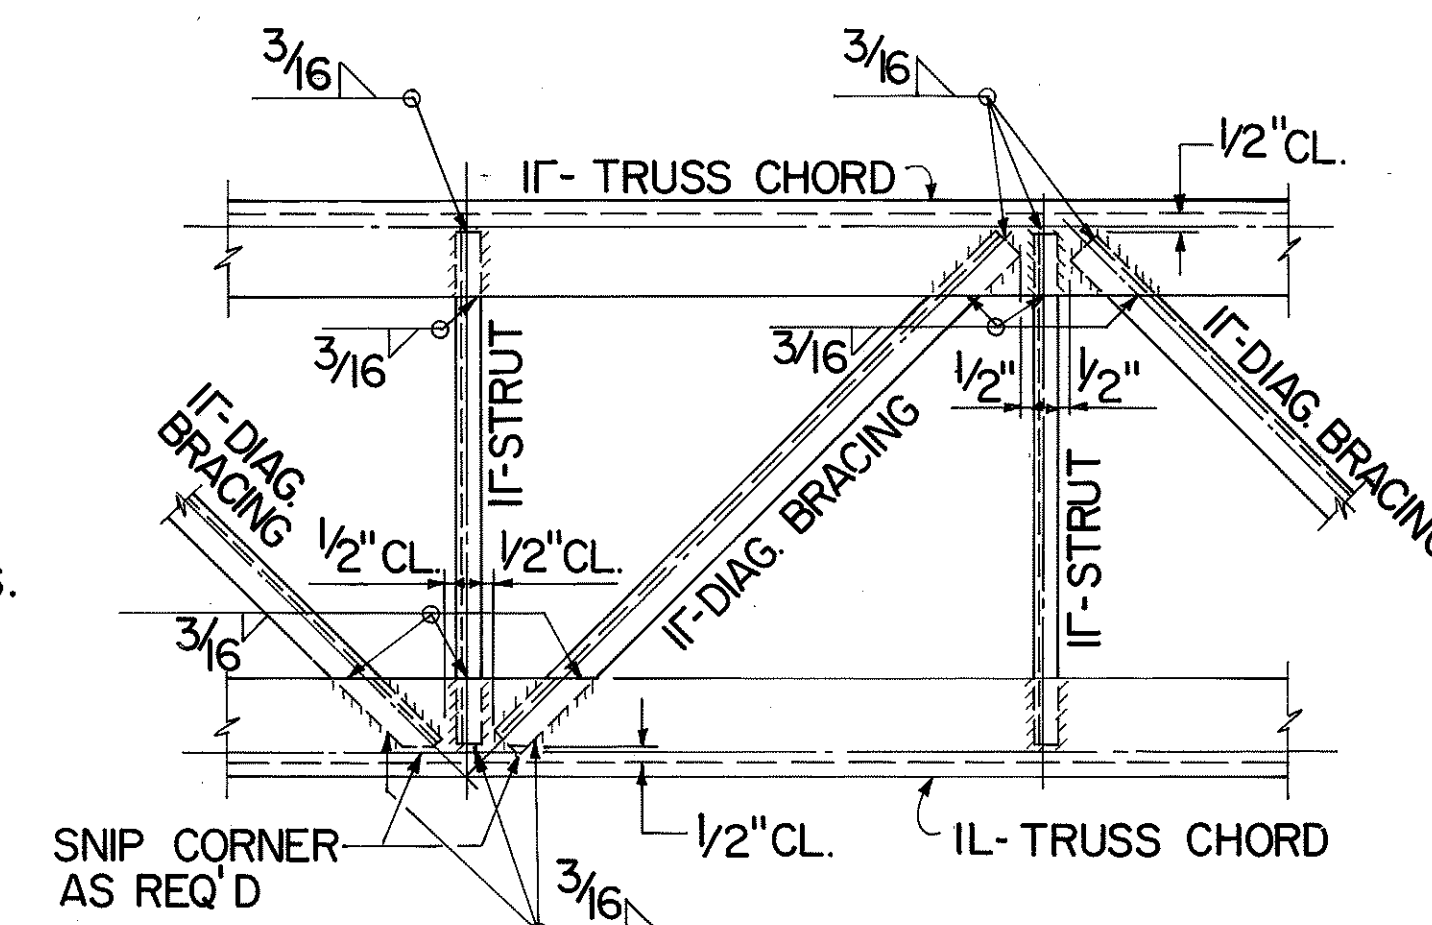

TYPICAL DETAIL 2

SS6, SS8, SS19

WIND BRACE CONNECTION

(TOP CHORD SHOWN - BOT. CHORD SIMILAR)

SCALE : 1 1/2" = 1' - 0"

ORIGINAL PLAN	SURVEY PLOTTED BY _____ DATE _____
NOTE BOOK	DRAWN BY <u>D. KUGEN</u> DATE <u>1/90</u>
	DESIGNED BY <u>H. P. CHEN</u> DATE <u>1/90</u>
	QUANTITIES BY <u>S. CHIN</u> DATE <u>3/92</u>
	CHECKED BY <u>K. WADA</u> DATE <u>1/90</u>
No. _____	

DATE	REVISION

STATE OF HAWAII
 DEPARTMENT OF TRANSPORTATION
 HIGHWAYS DIVISION







TRUSS CONNECTION DETAILS - I

SUPPORT STRUCTURES
INTERSTATE ROUTE H-3
F.A.I. PROJ. NO. I-H3-1 (66)

SCALE: AS SHOWN DATE: APR. 1992

SHEET No. SS190F OF 36 SHEETS

ORIGINAL: PLAN	SURVEY PLOTTED BY DRAWN BY <u>D. WUONG</u>	DATE <u>1/90</u>
NOTE BOOK	TRACED BY _____	"
	DESIGNED BY <u>K. WADA</u>	" <u>1/90</u>
	QUANTITIES BY <u>S. CHUN</u>	" <u>3/90</u>
	CHECKED BY <u>S. CHUN</u>	" <u>1/90</u>
NO. _____		

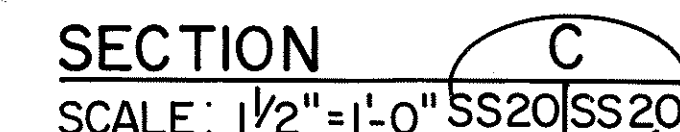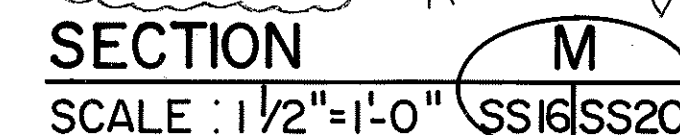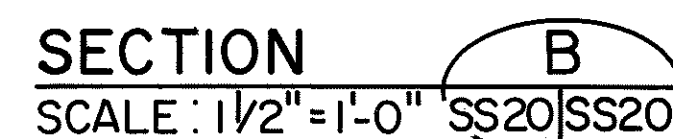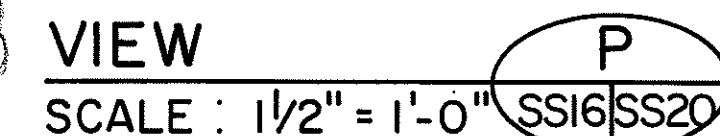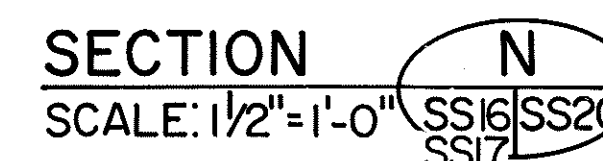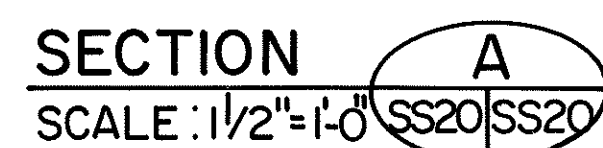

5/3/94	REVISE NOTE (SECT. 'A' 'B' & 'C')
	REVISE WELDS (SECT. 'N', 'P' & 'M')
	REVISE ANGLE. ADD GUSSET PLATE
	(SECT. 'C' & 'M')
	PER DCN 66-036
12/29/93	REV. DIM. OF TOP CHORD PLATE (SECT. 'M')
	DCN 66-027


STATE OF HAWAII
DEPARTMENT OF TRANSPORTATION
HIGHWAYS DIVISION

SUPPORT STRUCTURES
INTERSTATE ROUTE H-3
F.A.I. PROJ. NO. I-H3 - 1 (66)


1 1/2" = 1'-0" GRAPHIC SCALE

THIS WORK WAS PREPARED BY ME
OR UNDER MY SUPERVISION.
Shingang Chen



FED. ROAD DIST. NO.	STATE	FED. AID PROJ. NO.	FISCAL YEAR	SHEET NO.	TOTAL SHEETS
HAWAII	HAW.	I-H3-1(66)	1992	383	440

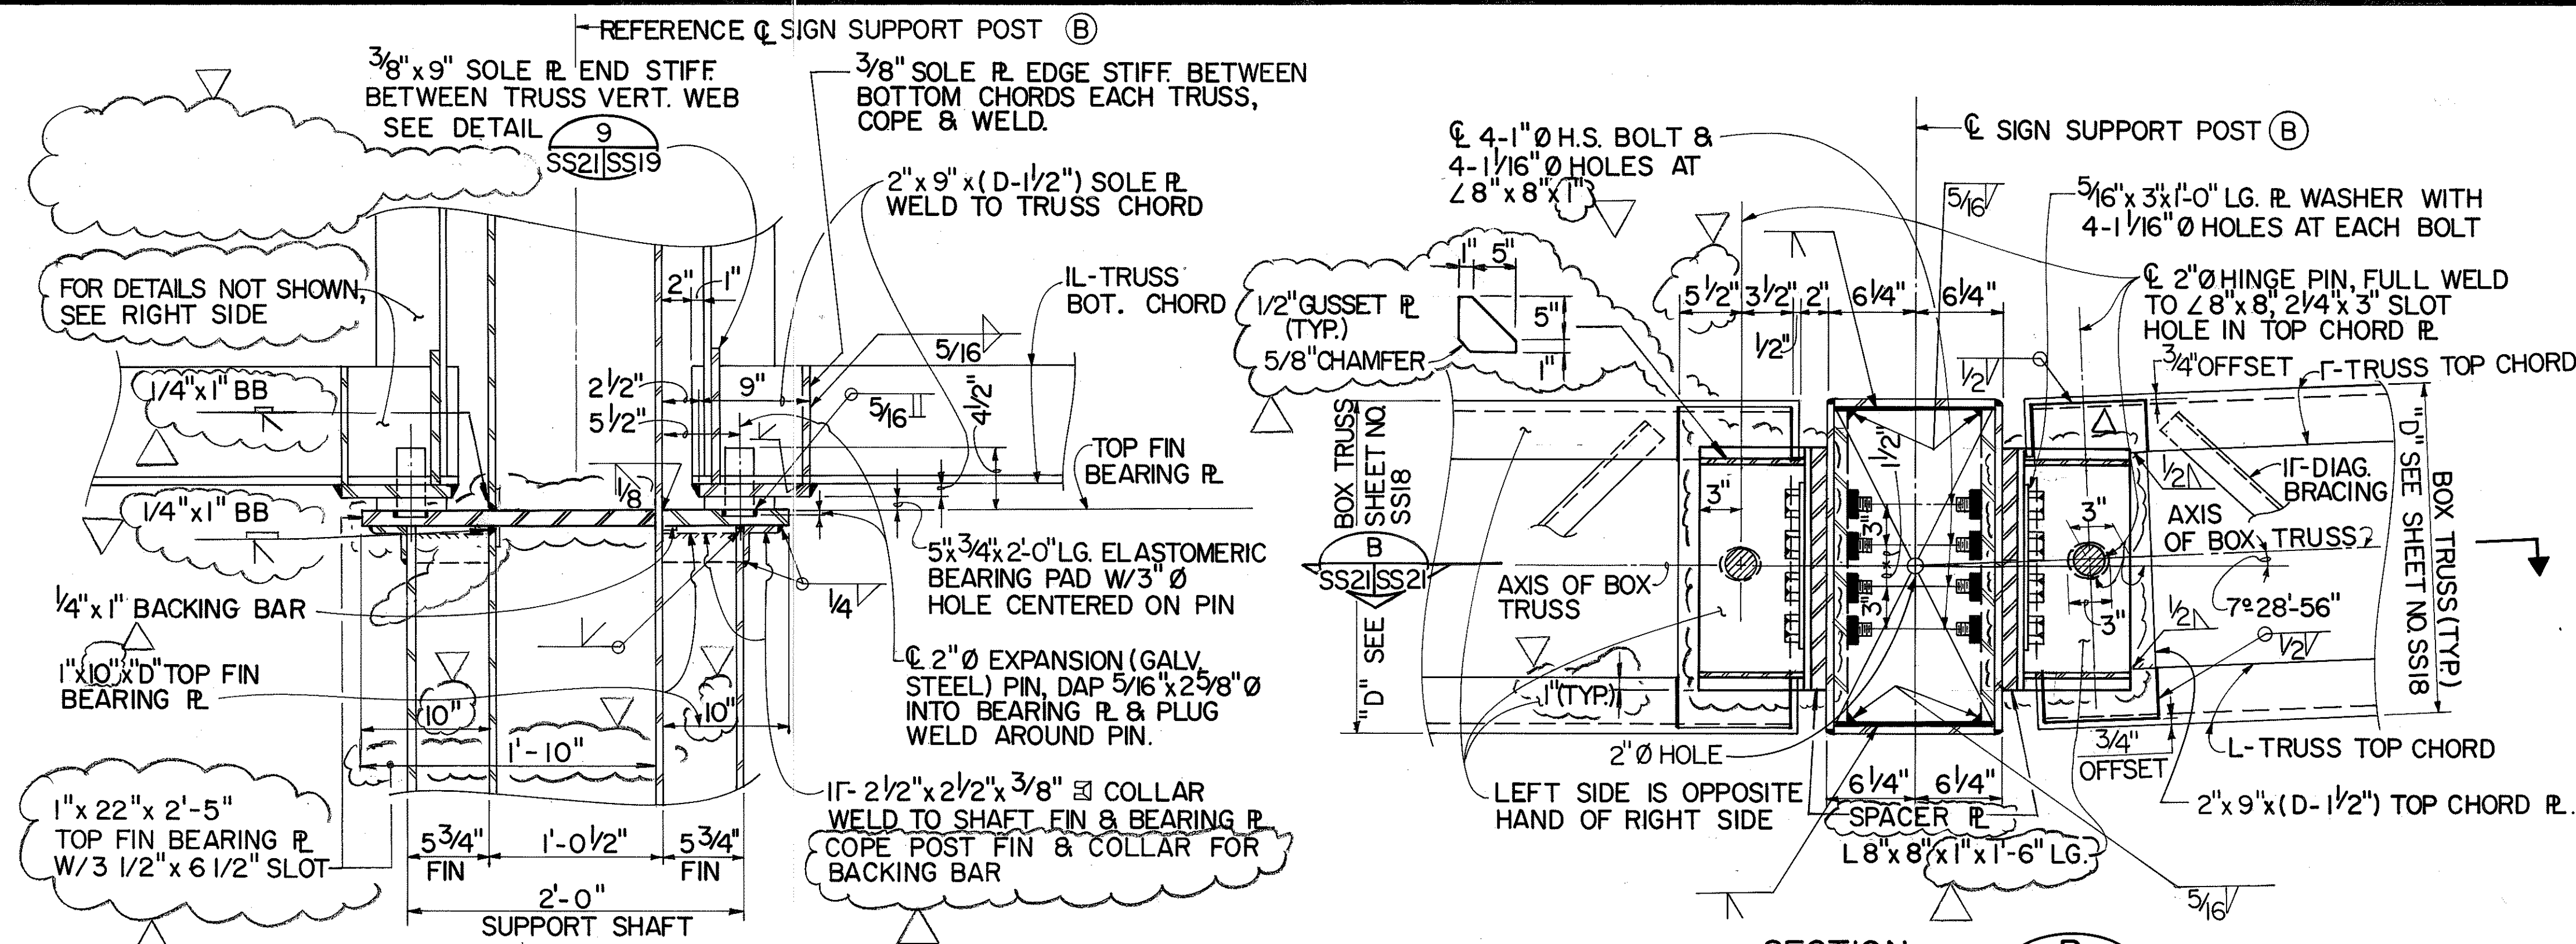

SECTION R
SCALE: 1/2" = 1'-0" SS17/SS21

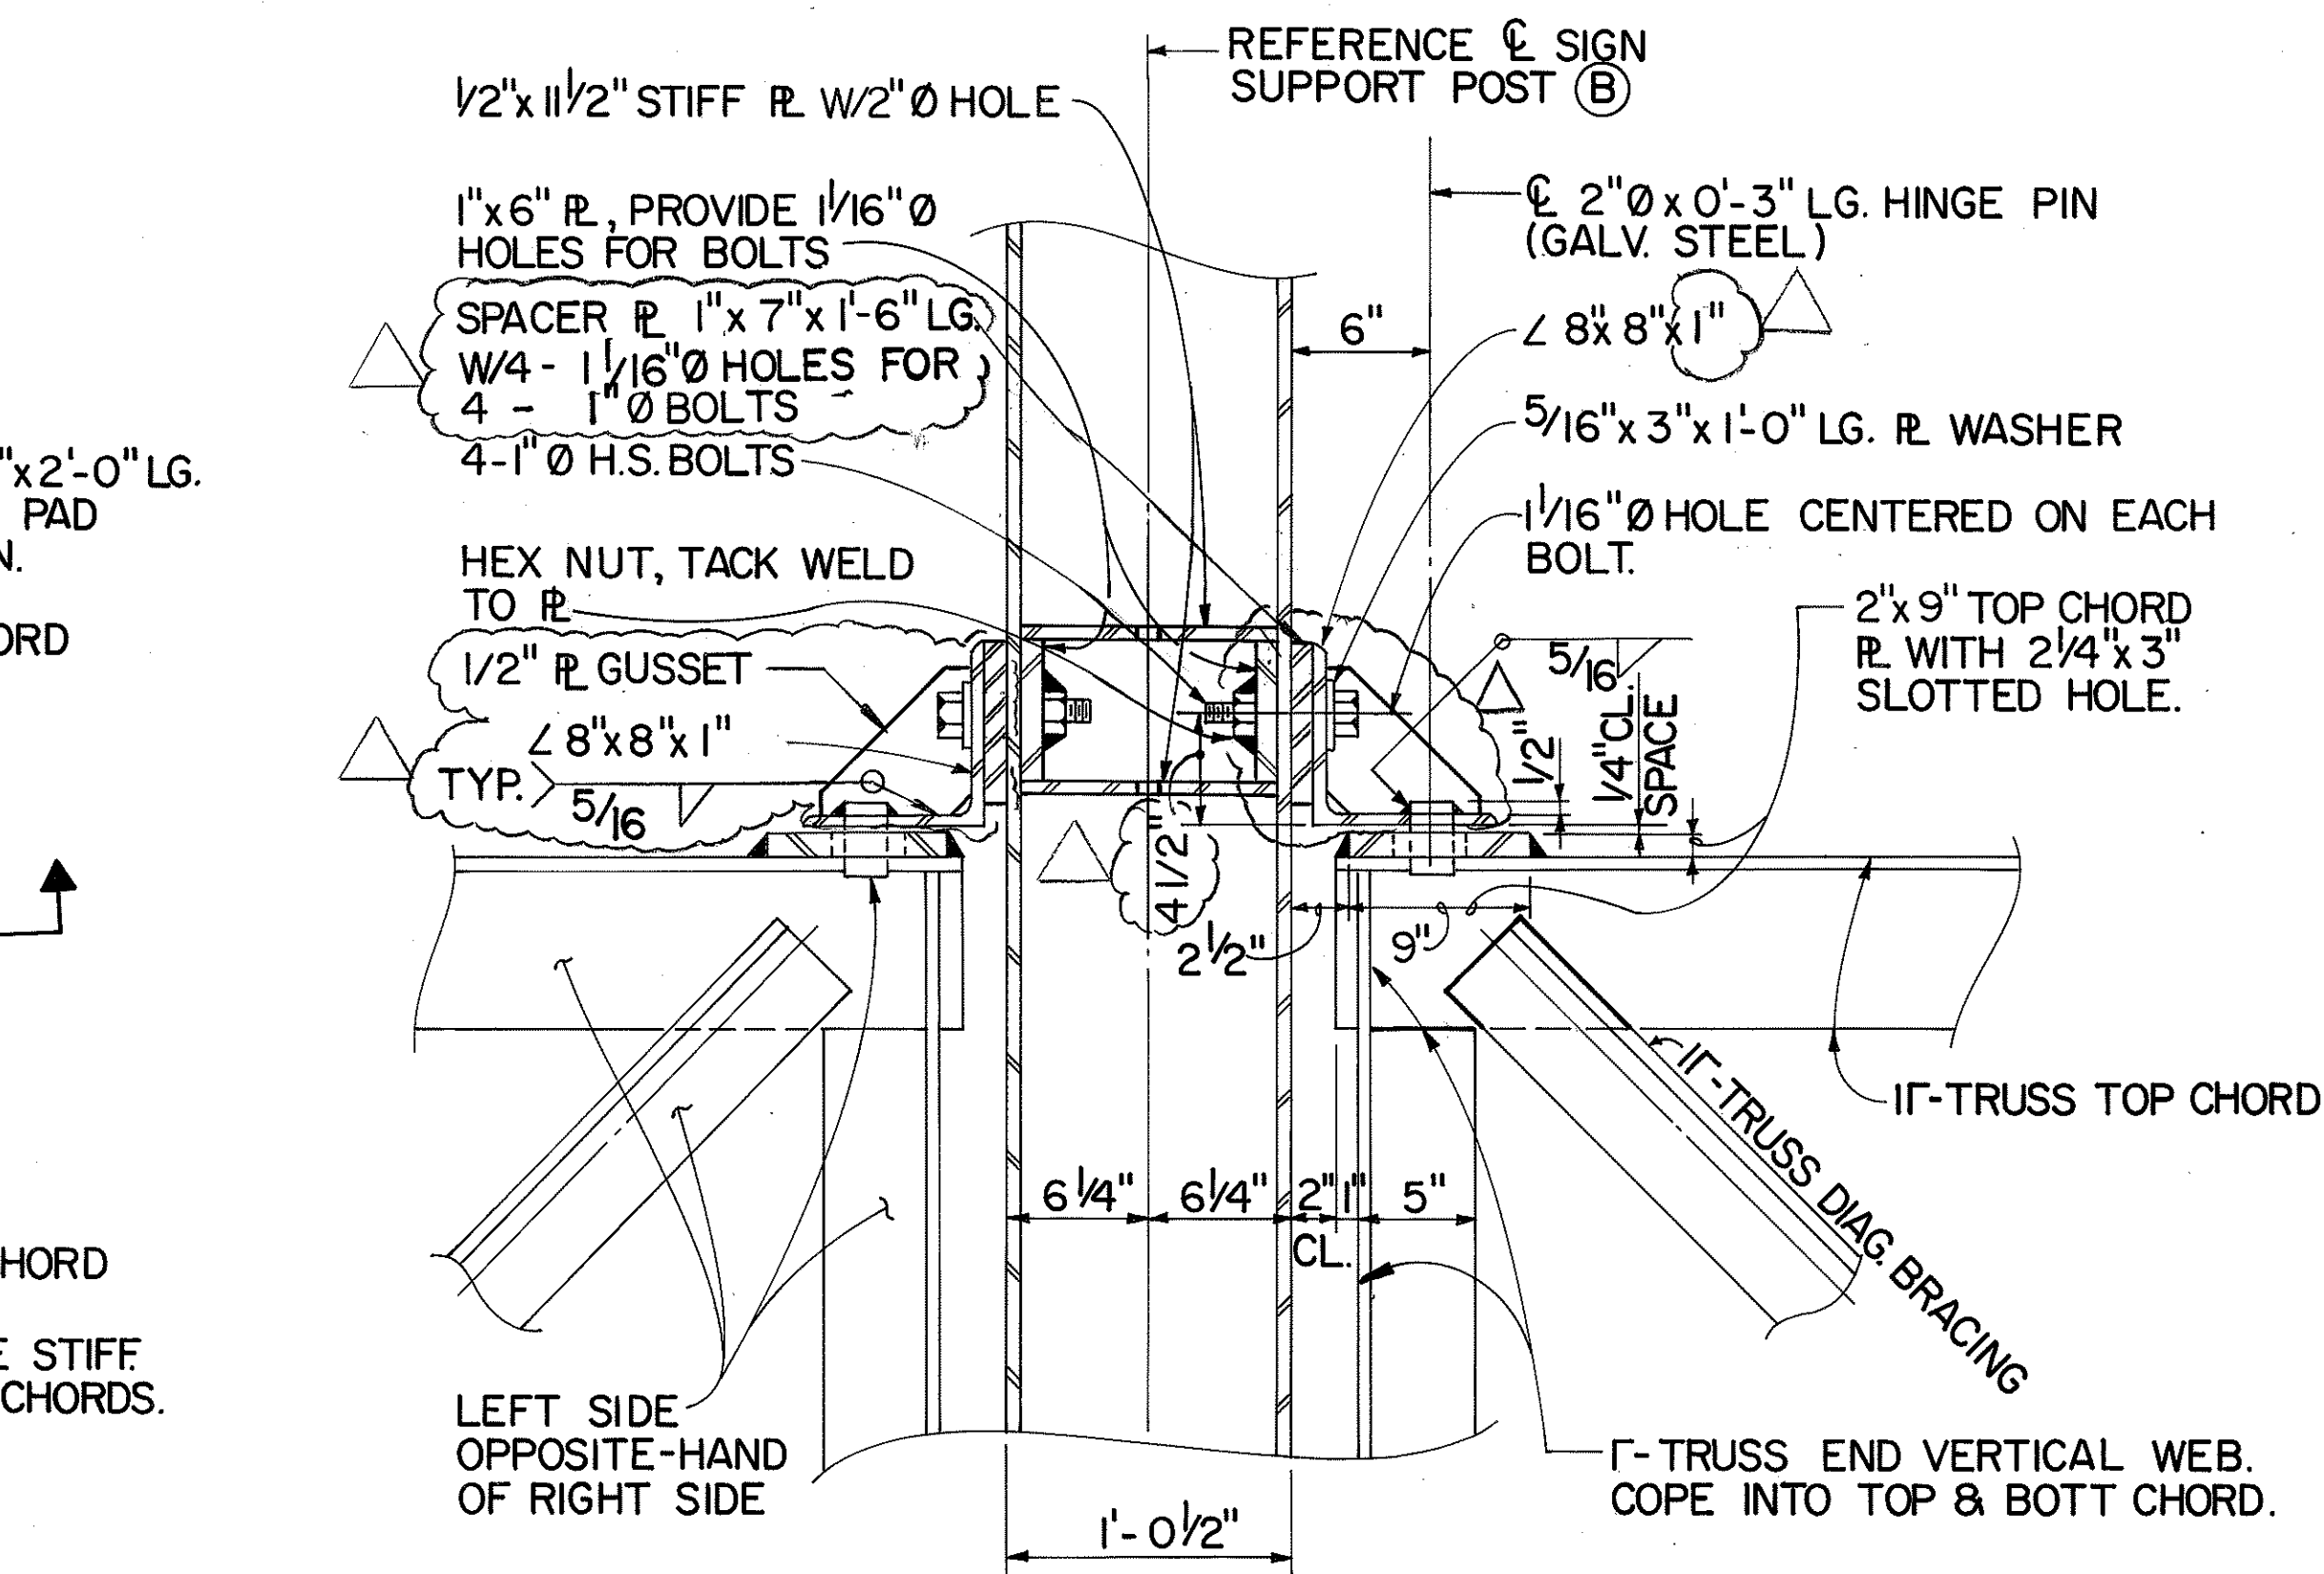


SECTION S
SCALE: 1/2" = 1'-0" SS17/SS21

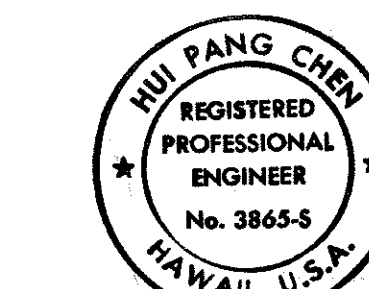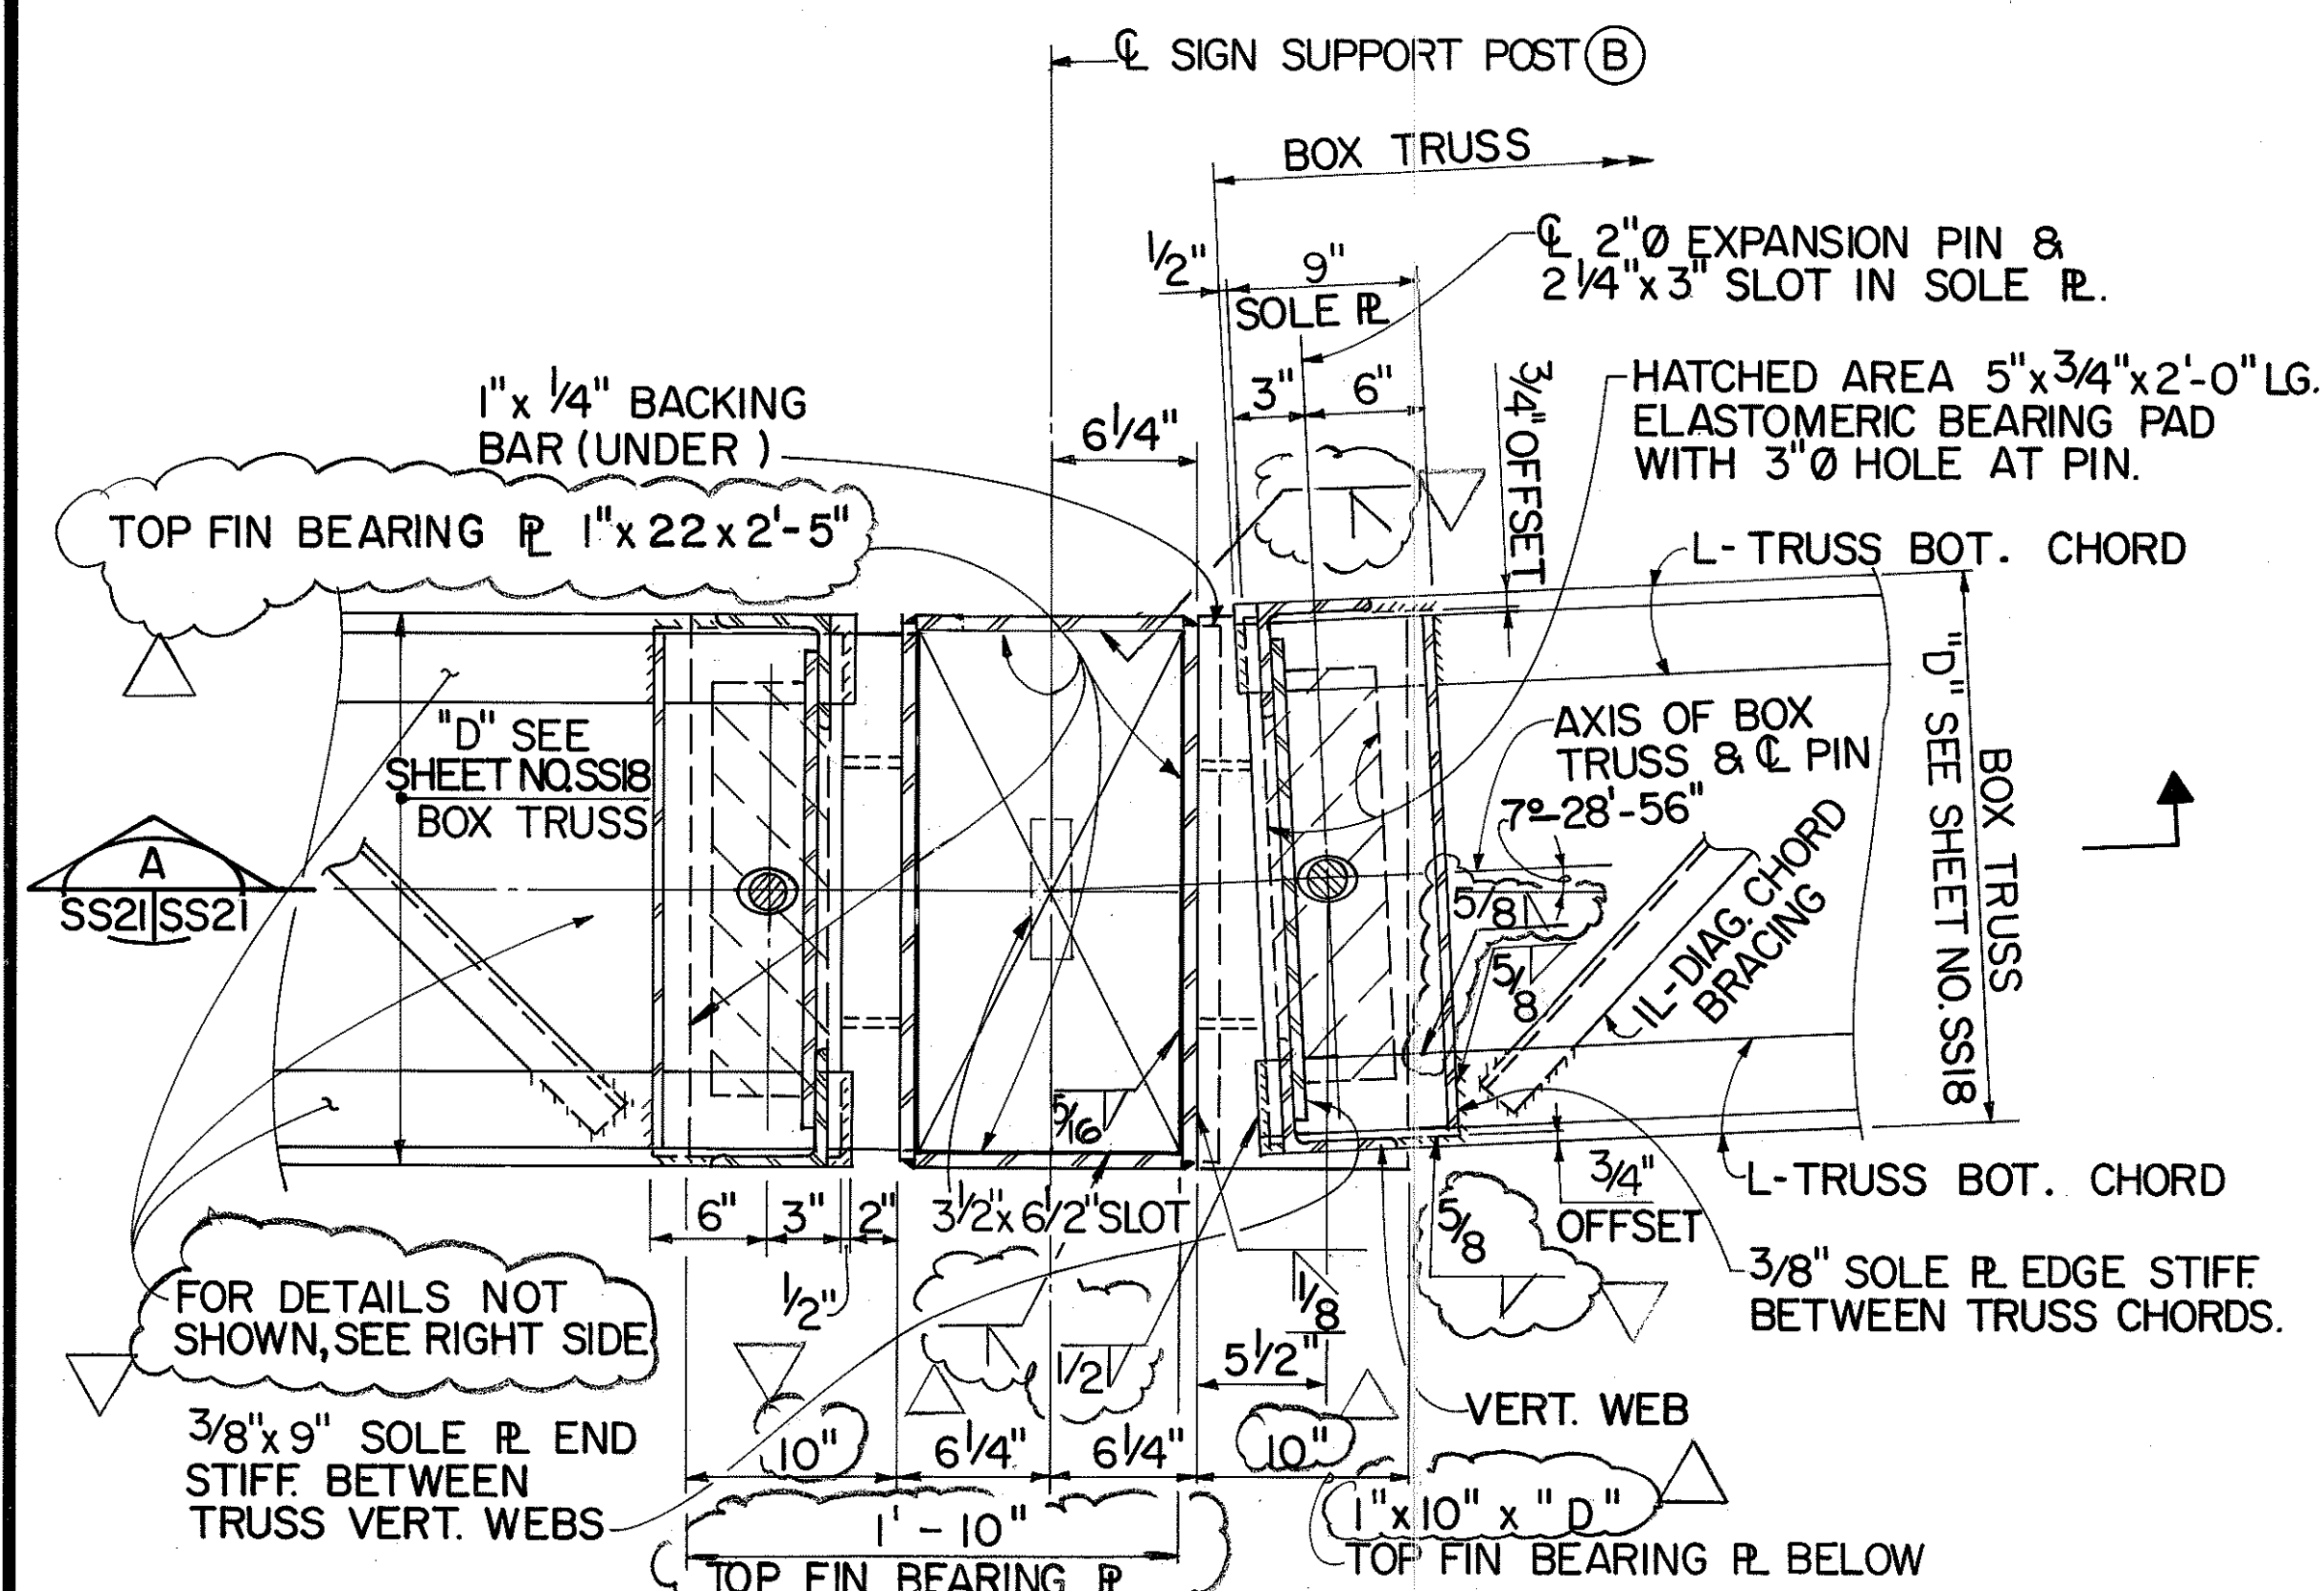


THIS WORK WAS PREPARED BY ME
OR UNDER MY SUPERVISION.
Hui Pang Chen

3/11/94	REVISE WELDS. DELETE STIFFENER R.
	REVISE BEARING R.
	REVISE ANGLE-ADD GUSSET R's PER DCN 66-036
DATE	REVISION
STATE OF HAWAII DEPARTMENT OF TRANSPORTATION HIGHWAYS DIVISION	
TRUSS CONNECTION DETAILS-3	
SUPPORT STRUCTURES INTERSTATE ROUTE H-3 F.A.I. PROJ. NO. I-H3-1(66)	
SCALE: AS SHOWN	DATE: APR. 1992
SHEET NO. SS21 OF 36 SHEETS	


FED. ROAD DIST. NO.	STATE	FED. AID PROJ. NO.	FISCAL YEAR	SHEET NO.	TOTAL SHEETS
HAWAII	HAW.	I-H3-1 (66)	1992	384	440

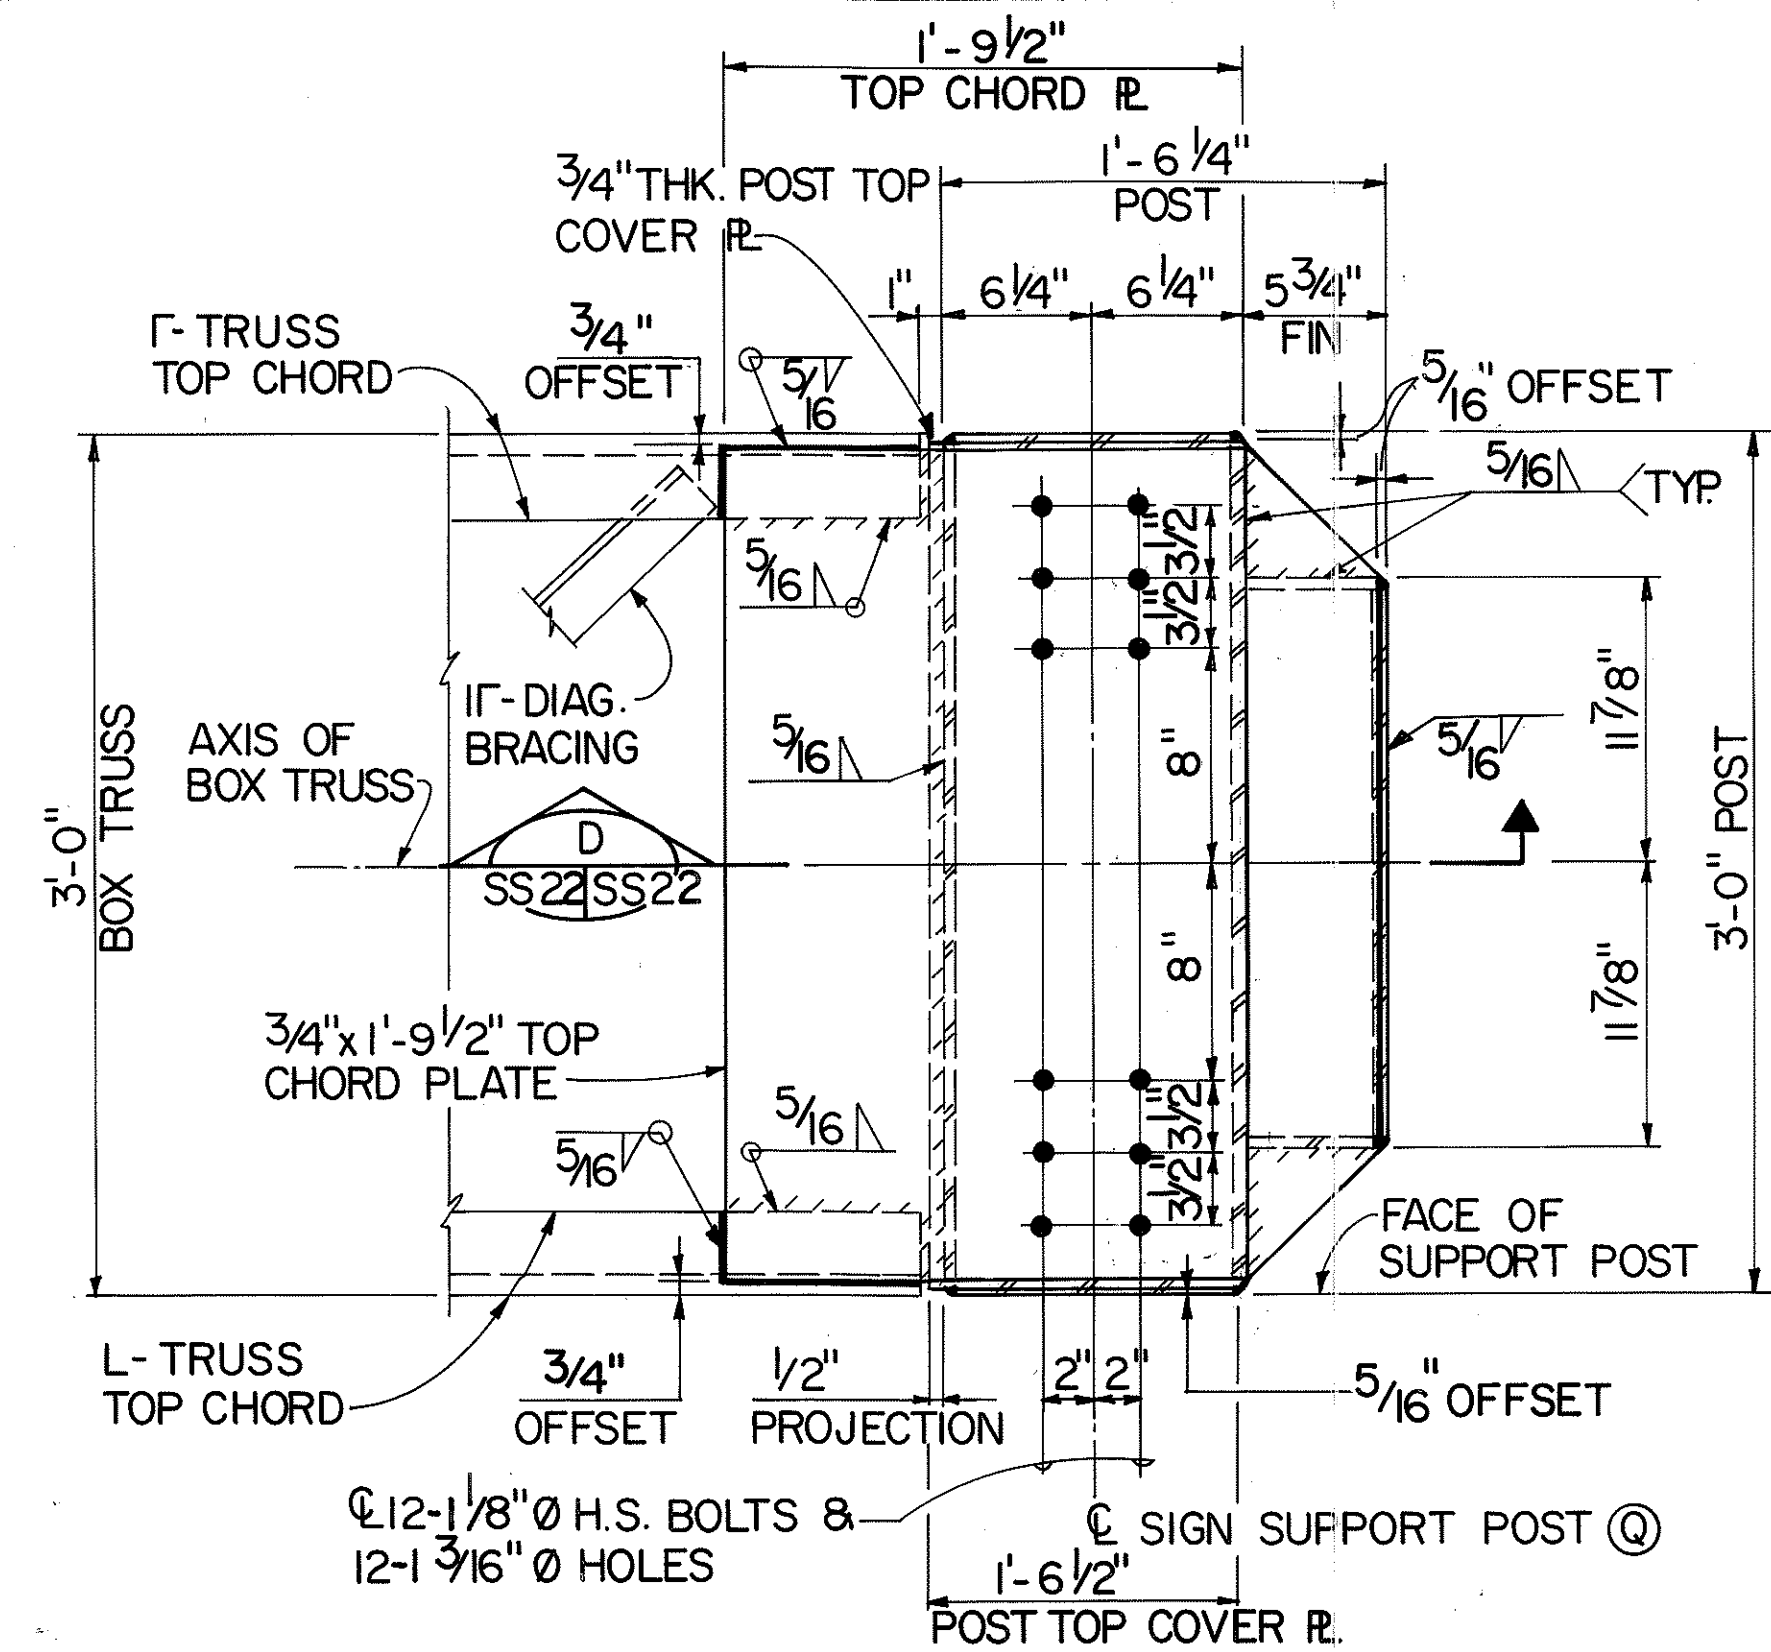


SECTION B
SCALE: 1/2" = 1'-0" SS6 SS22

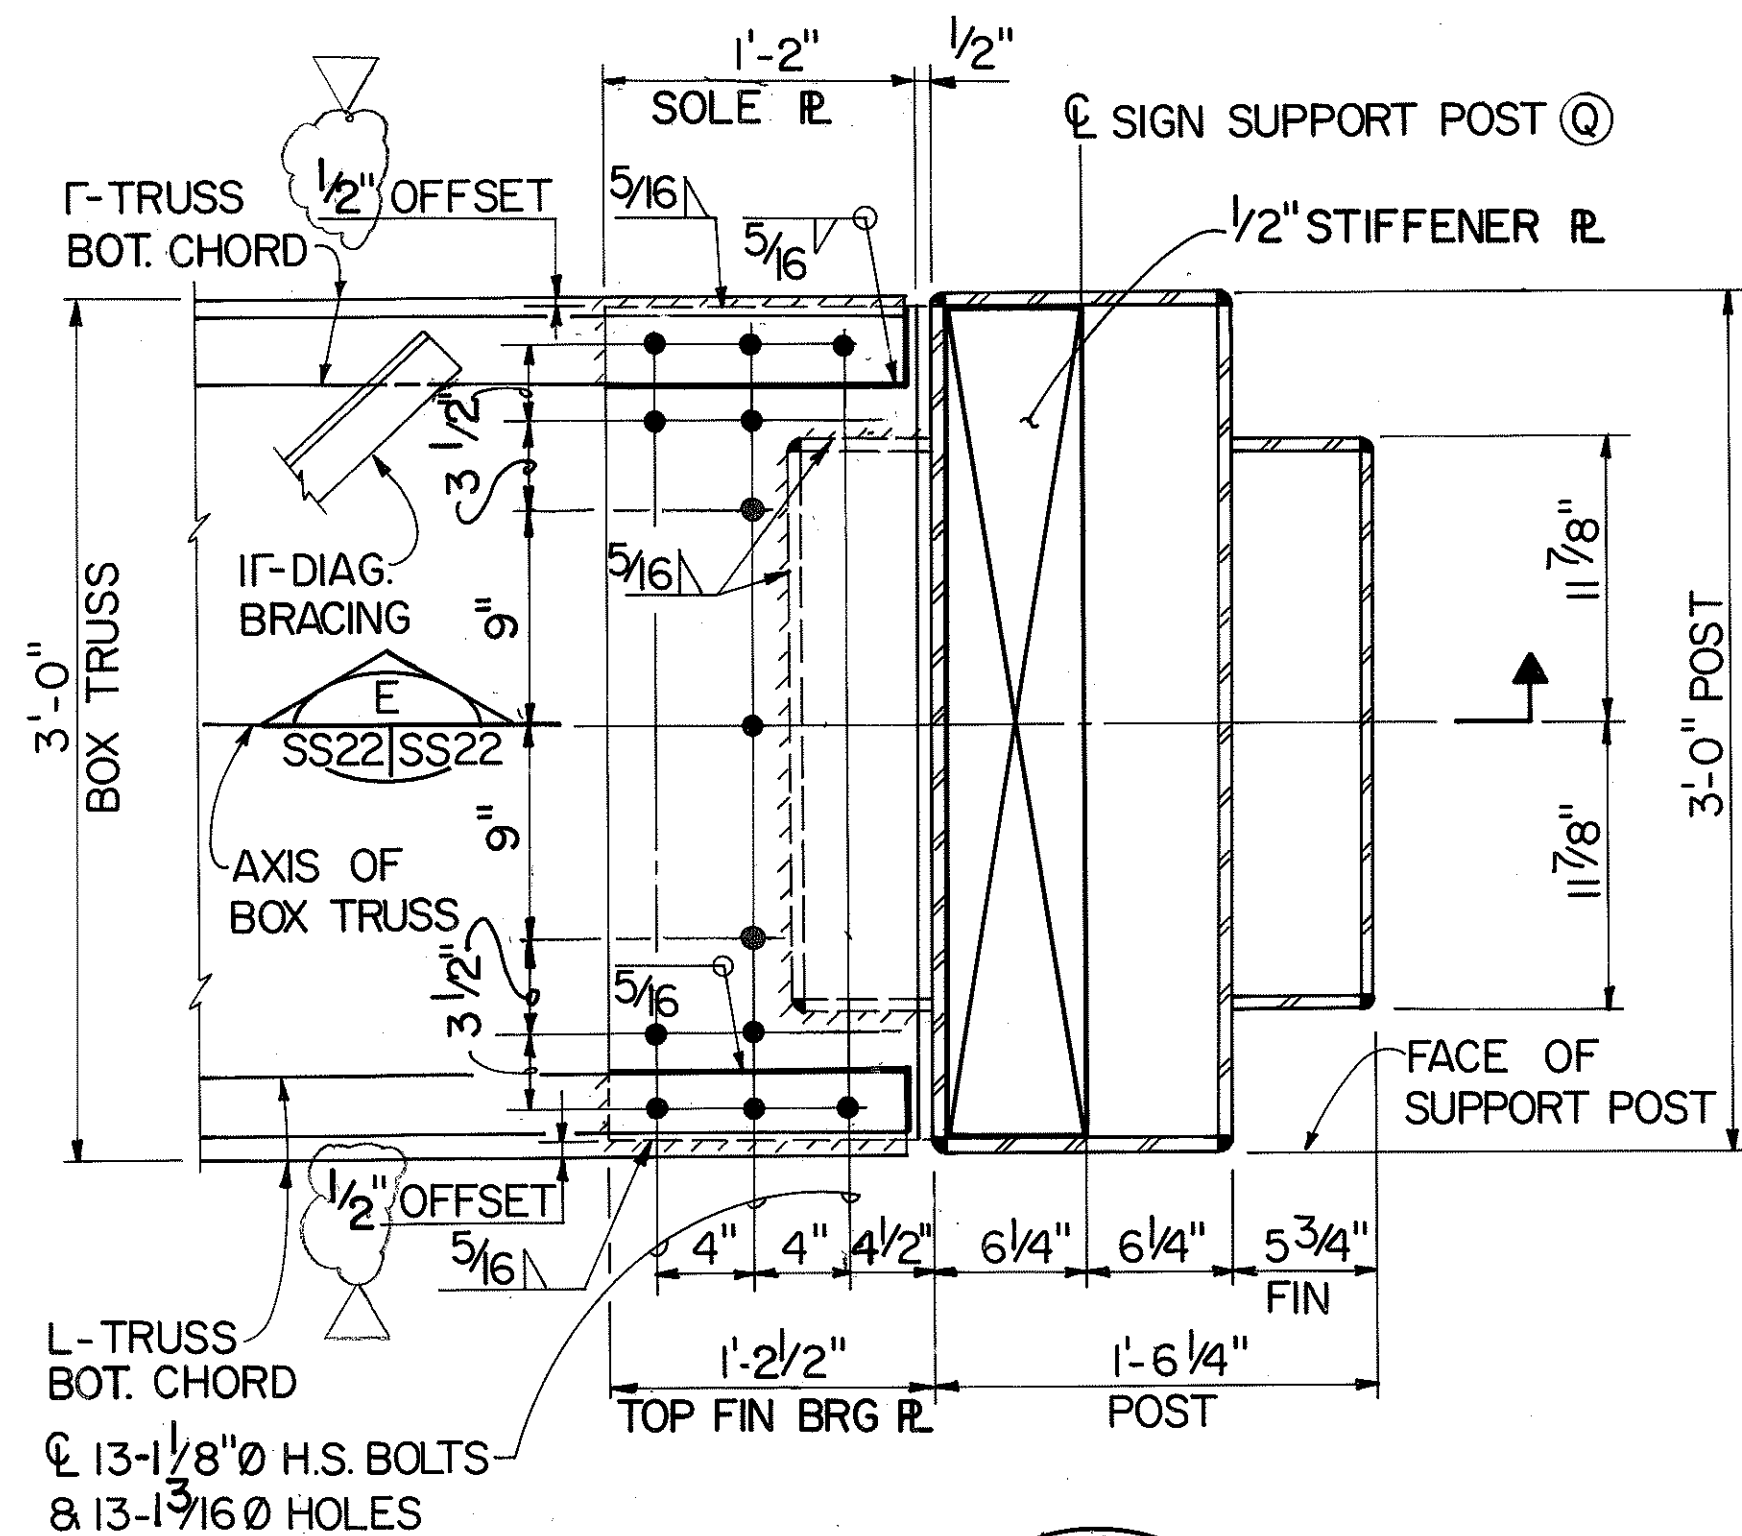

SECTION C
SCALE: 1/2" = 1'-0" SS6 SS22

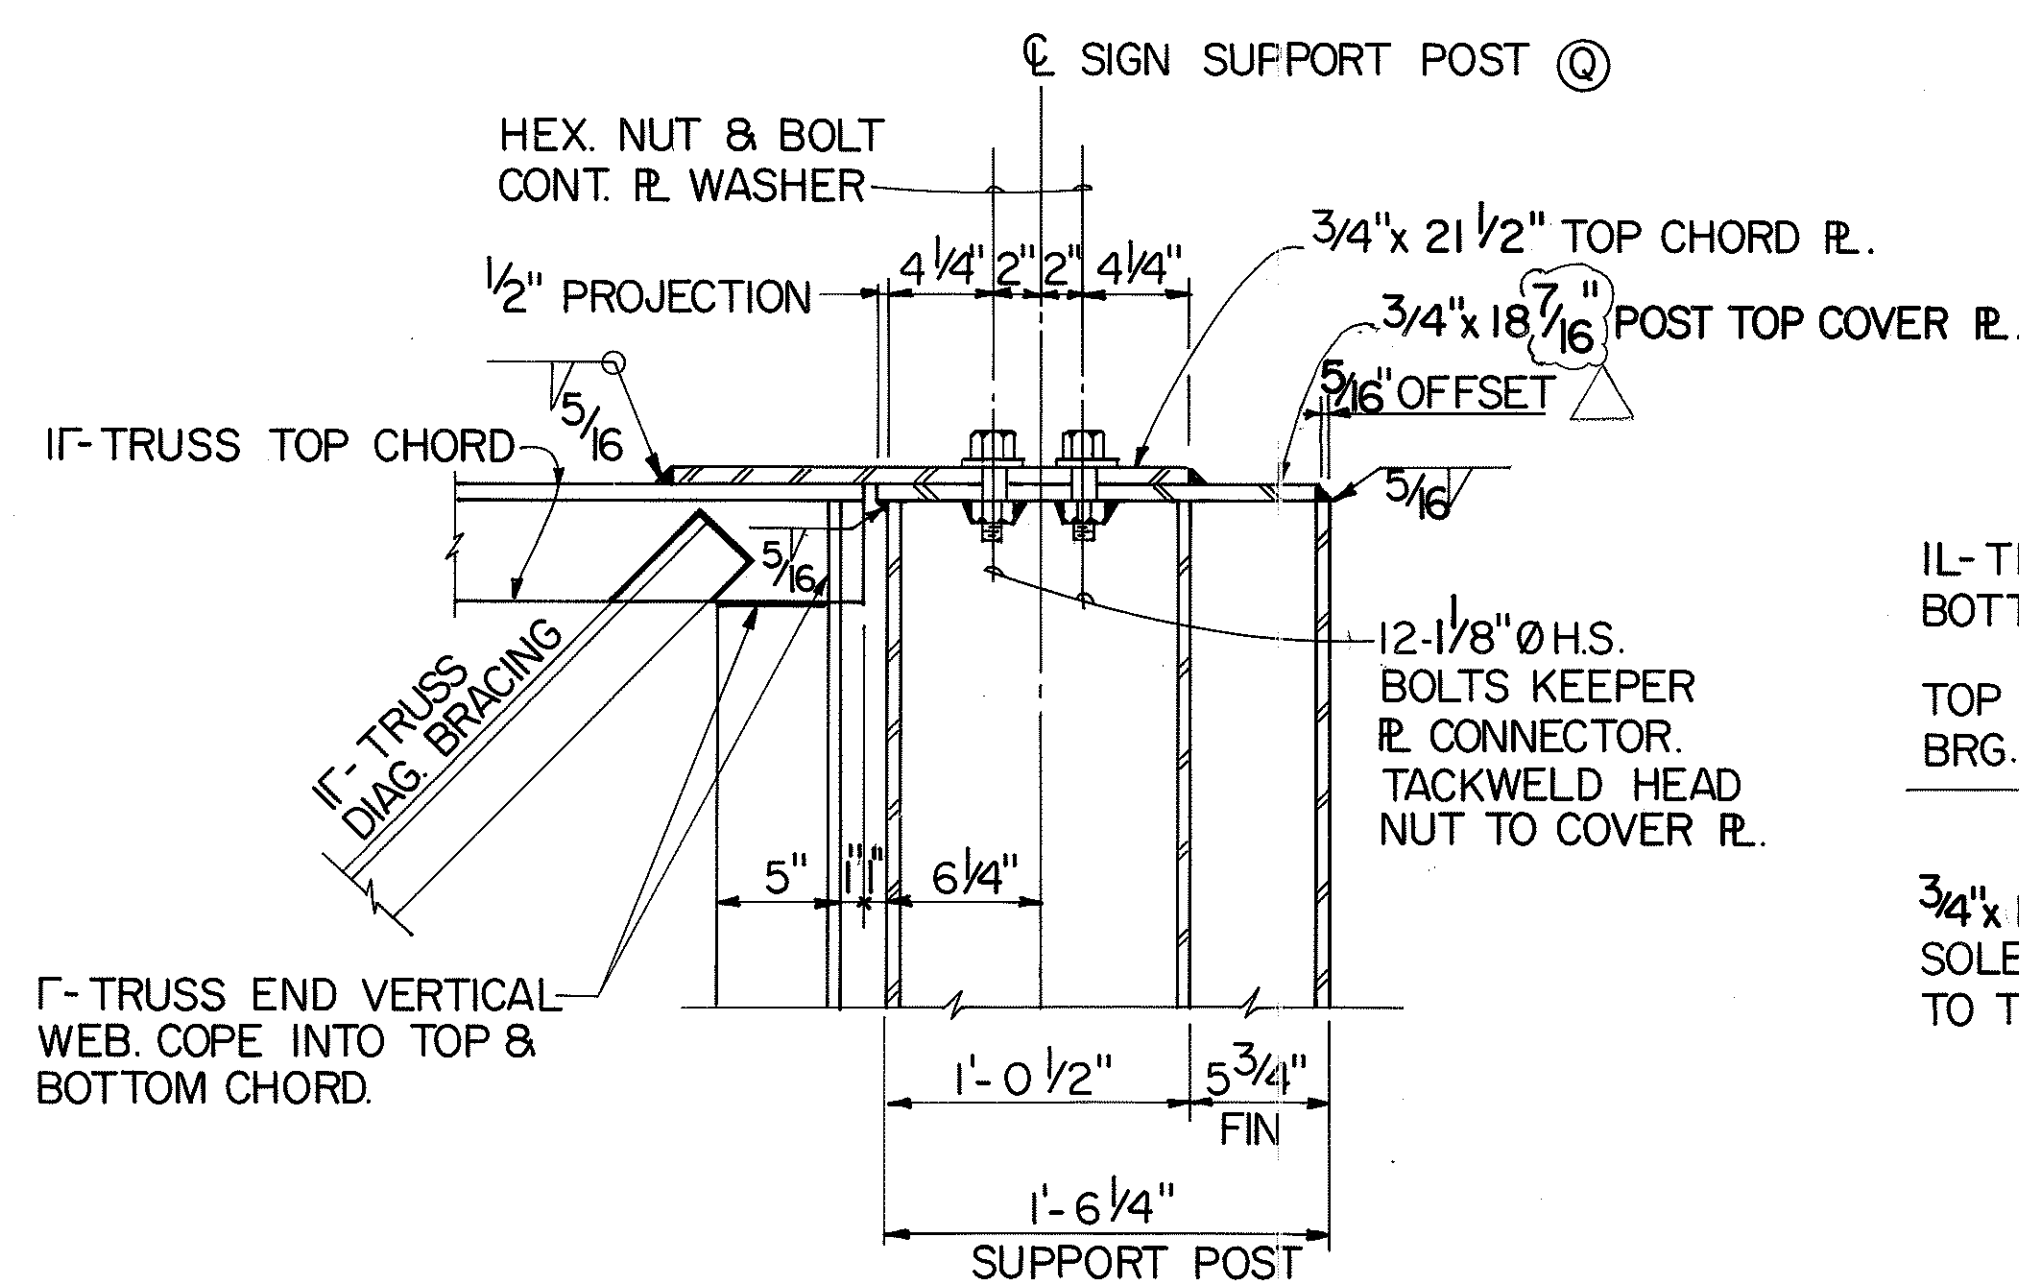

SECTION D
SCALE: 1/2" = 1'-0" SS22 SS22

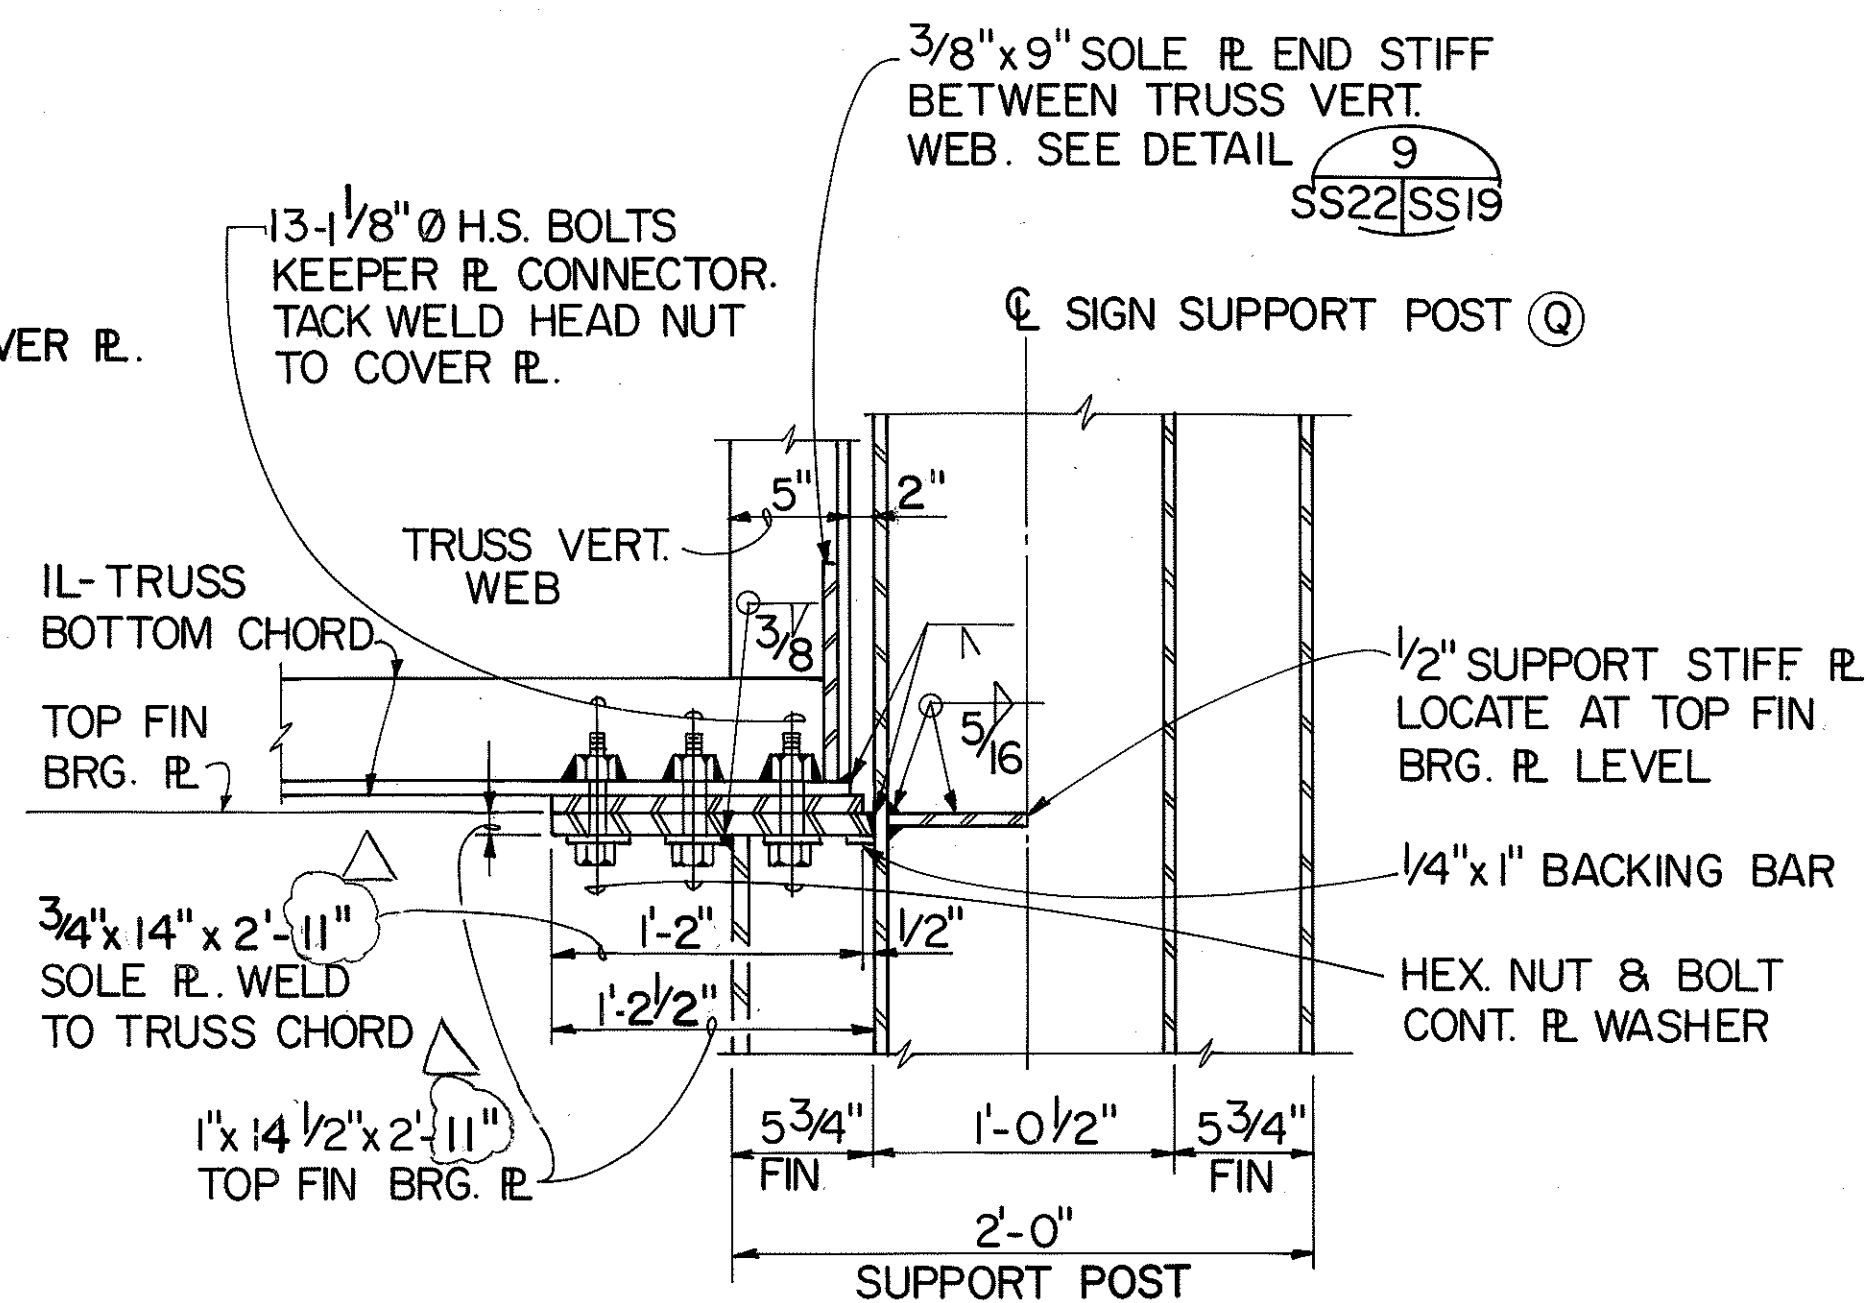


SECTION E
SCALE: 1/2" = 1'-0" SS22 SS22








THIS WORK WAS PREPARED BY ME
OR UNDER MY SUPERVISION.
Hui Pang Chen
REGISTERED PROFESSIONAL ENGINEER
No. 3865-S
HAWAII, U.S.A.

2/25/94	REVISE DIMENSION PER DCN 66-036
12/29/93	REV. TRUSS CONNECTION PER DCN 66-027
DATE	REVISION
STATE OF HAWAII DEPARTMENT OF TRANSPORTATION HIGHWAYS DIVISION TRUSS CONNECTION DETAILS-4 SUPPORT STRUCTURES INTERSTATE ROUTE H-3 F.A.I. PROJ. NO. I-H3-1 (66) SCALE: AS SHOWN DATE: APR. 1992 SHEET NO. SS22 OF 36 SHEETS	

FED. ROAD DIST. NO.	STATE	FED. AID PROJ. NO.	FISCAL YEAR	SHEET NO.	TOTAL SHEETS
HAWAII	HAW.	I-H3-1(66)	1992	385	440

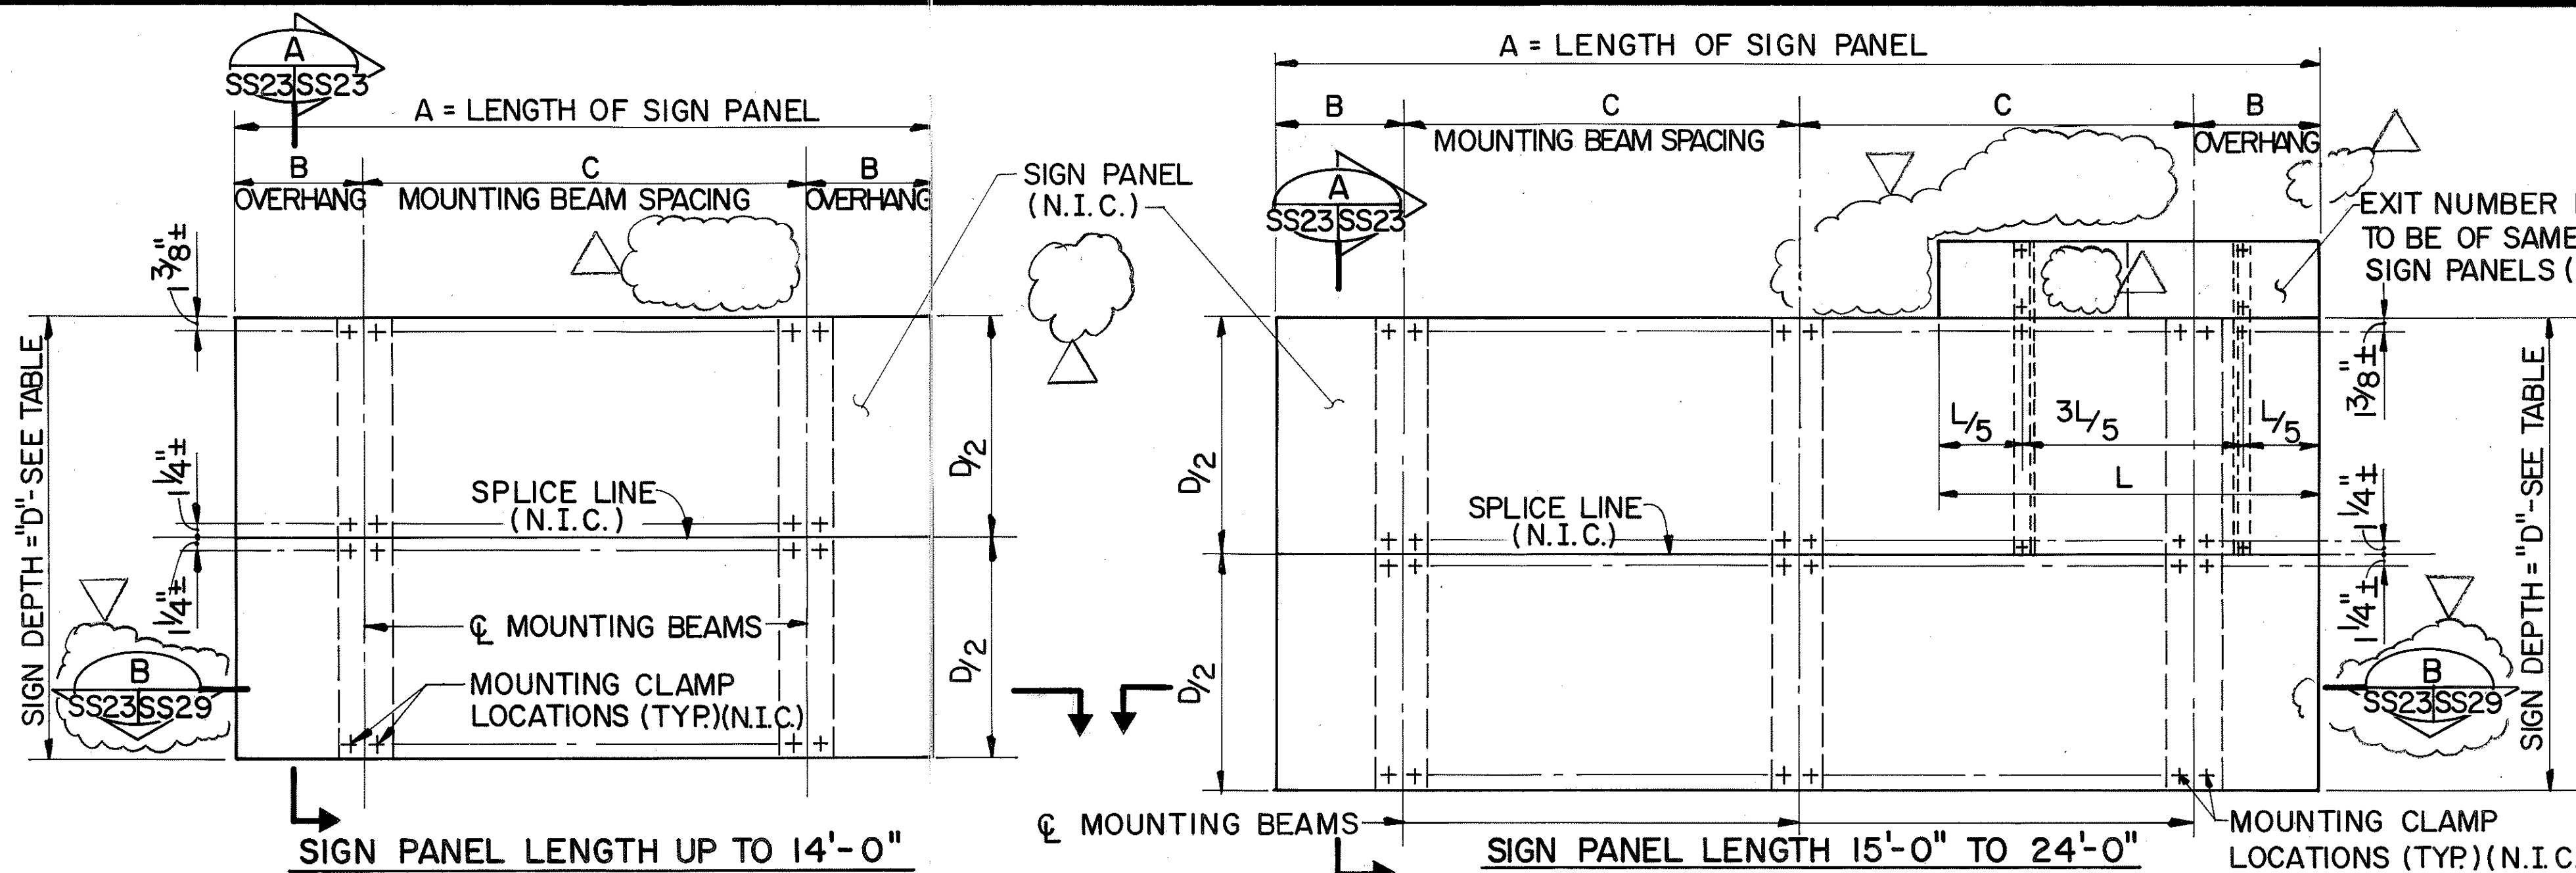

MOUNTING BEAM SCHEDULE					
LOCATION	SIGN PANEL LENGTH A	NUMBER MOUNTING BEAMS	SIGN PANEL OVERHANG B	MOUNTING BEAM SPACING C	SIGN DEPTH D
HALAWA	O.B. STA. 573+40	2	2'-0"	6'-0"	6'-0"
HAIKU	O.B. STA. 273+70.11	3	2'-0"	6'-6"	10'-0"
	I.B. STA. 287+85.53	2	2'-0"	6'-0"	6'-0"
	O.B. STA. 310+85.11	3	2'-0"	6'-6"	10'-0"

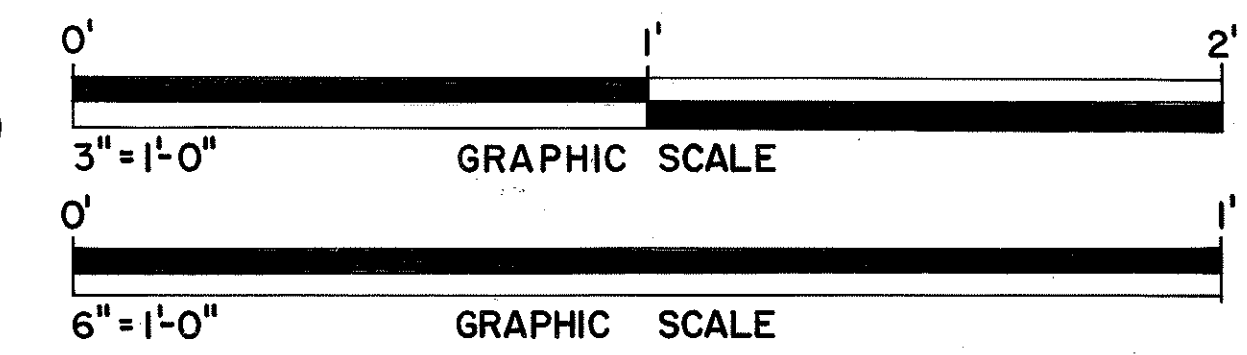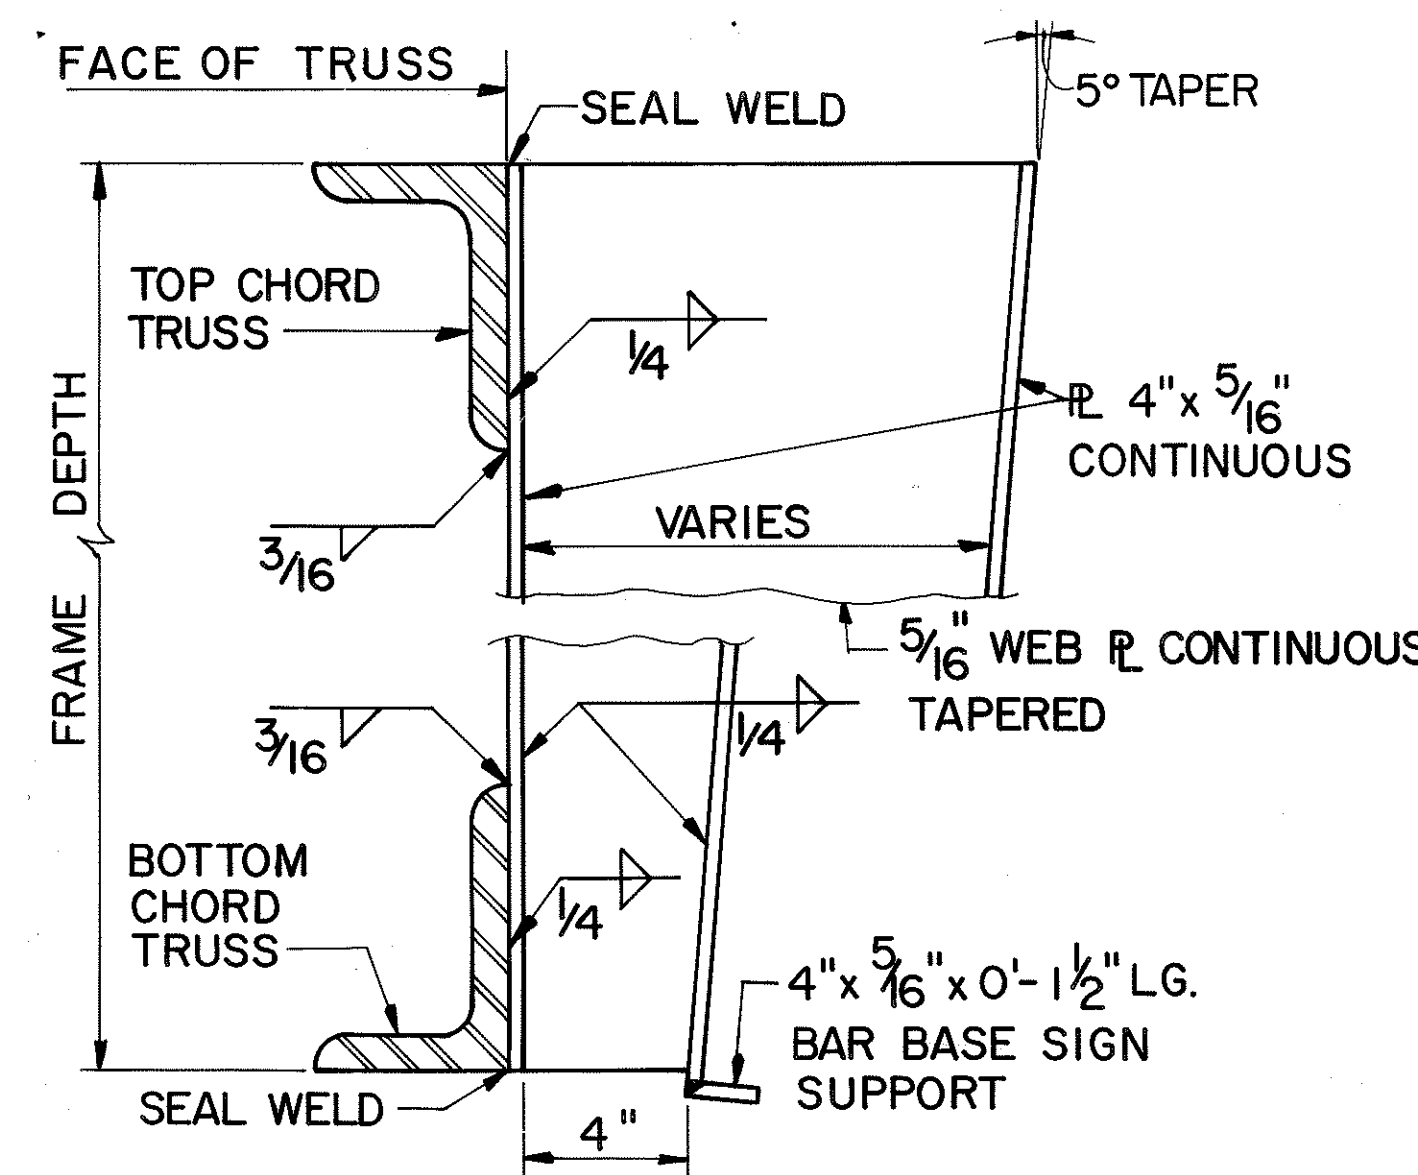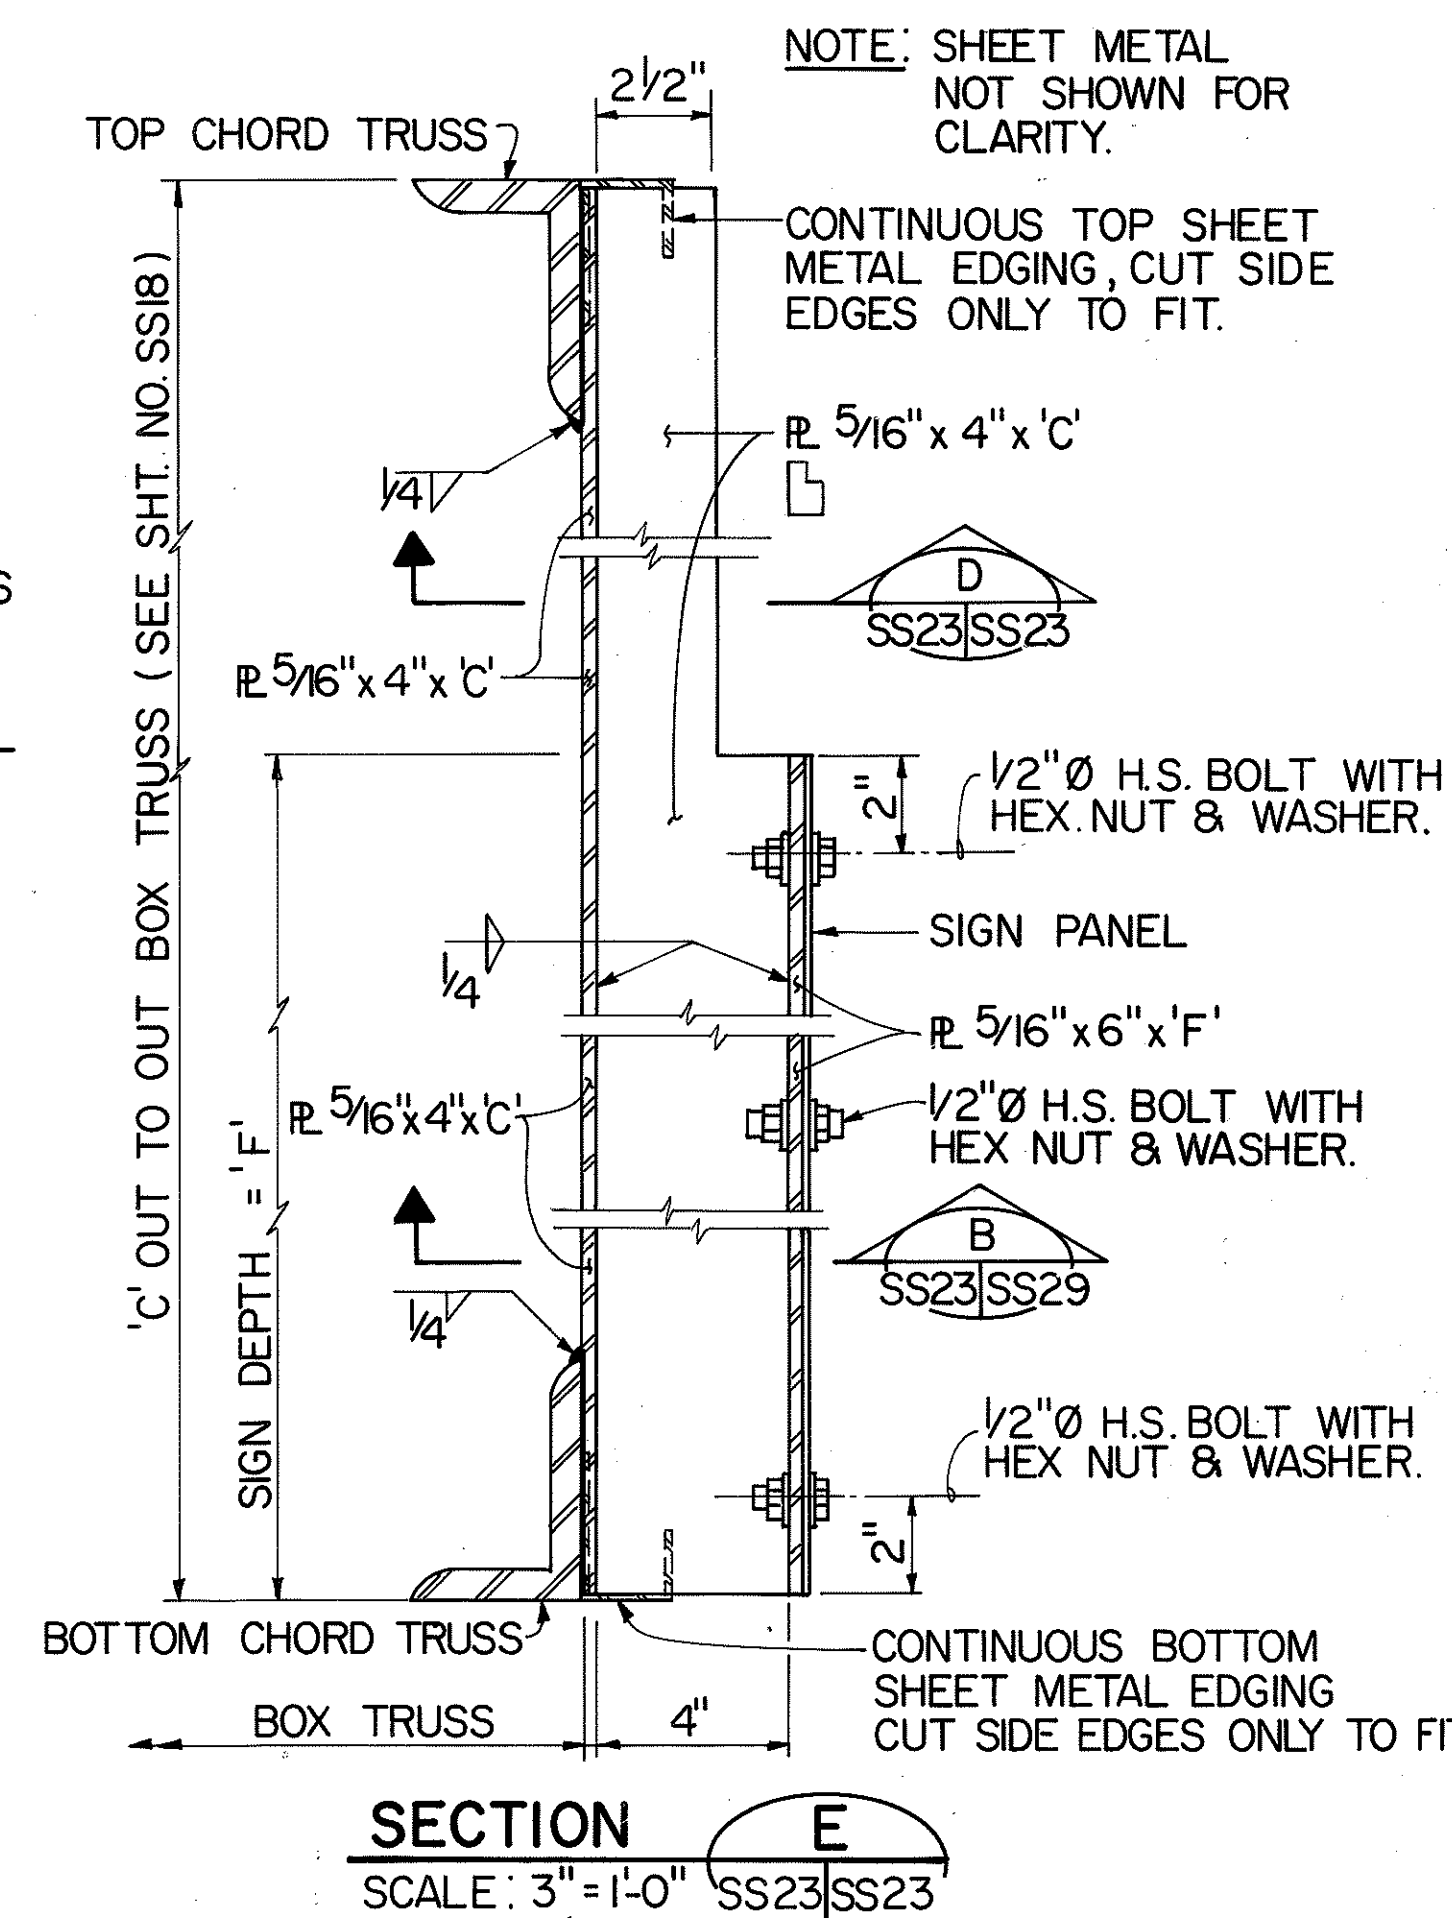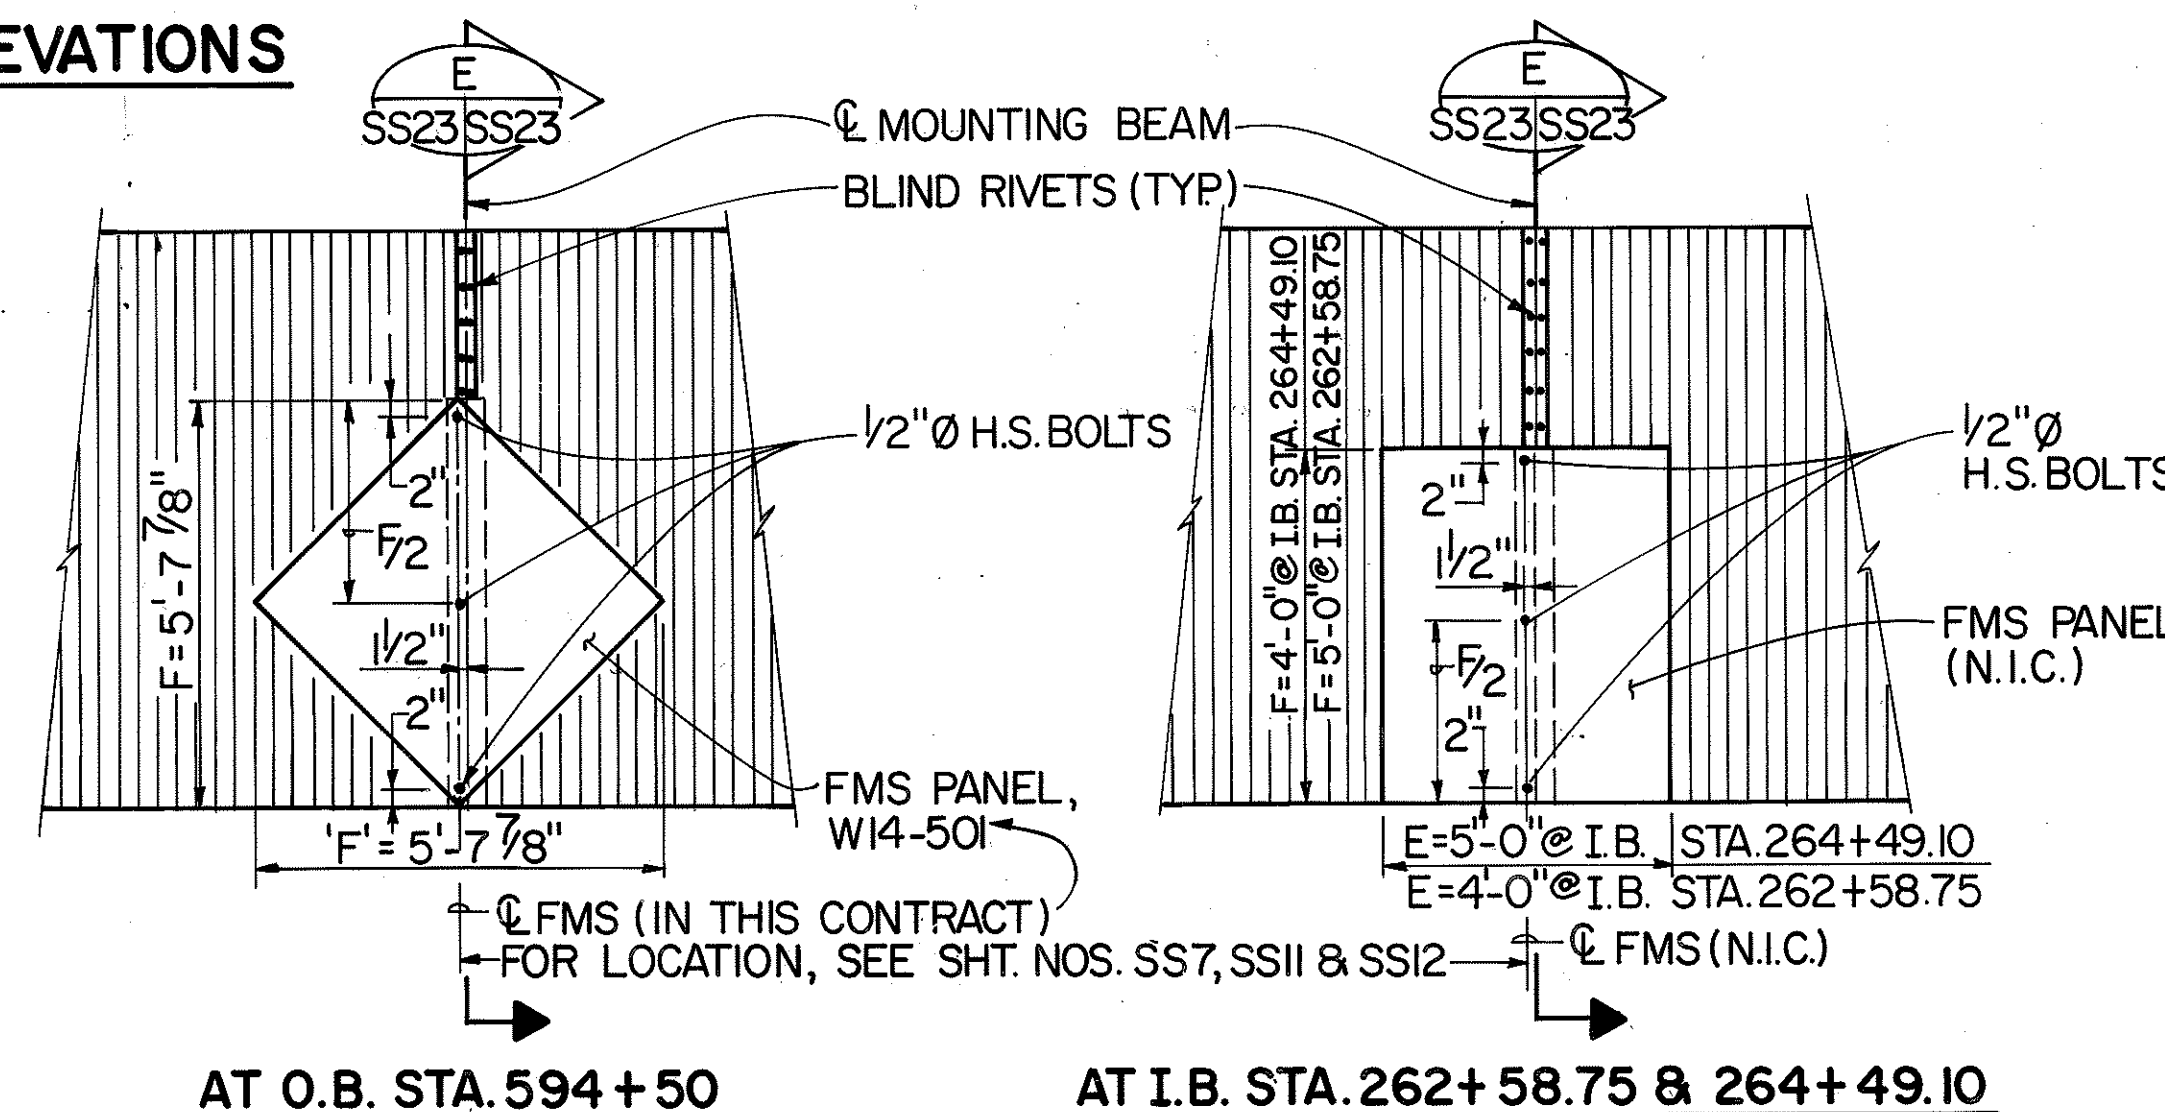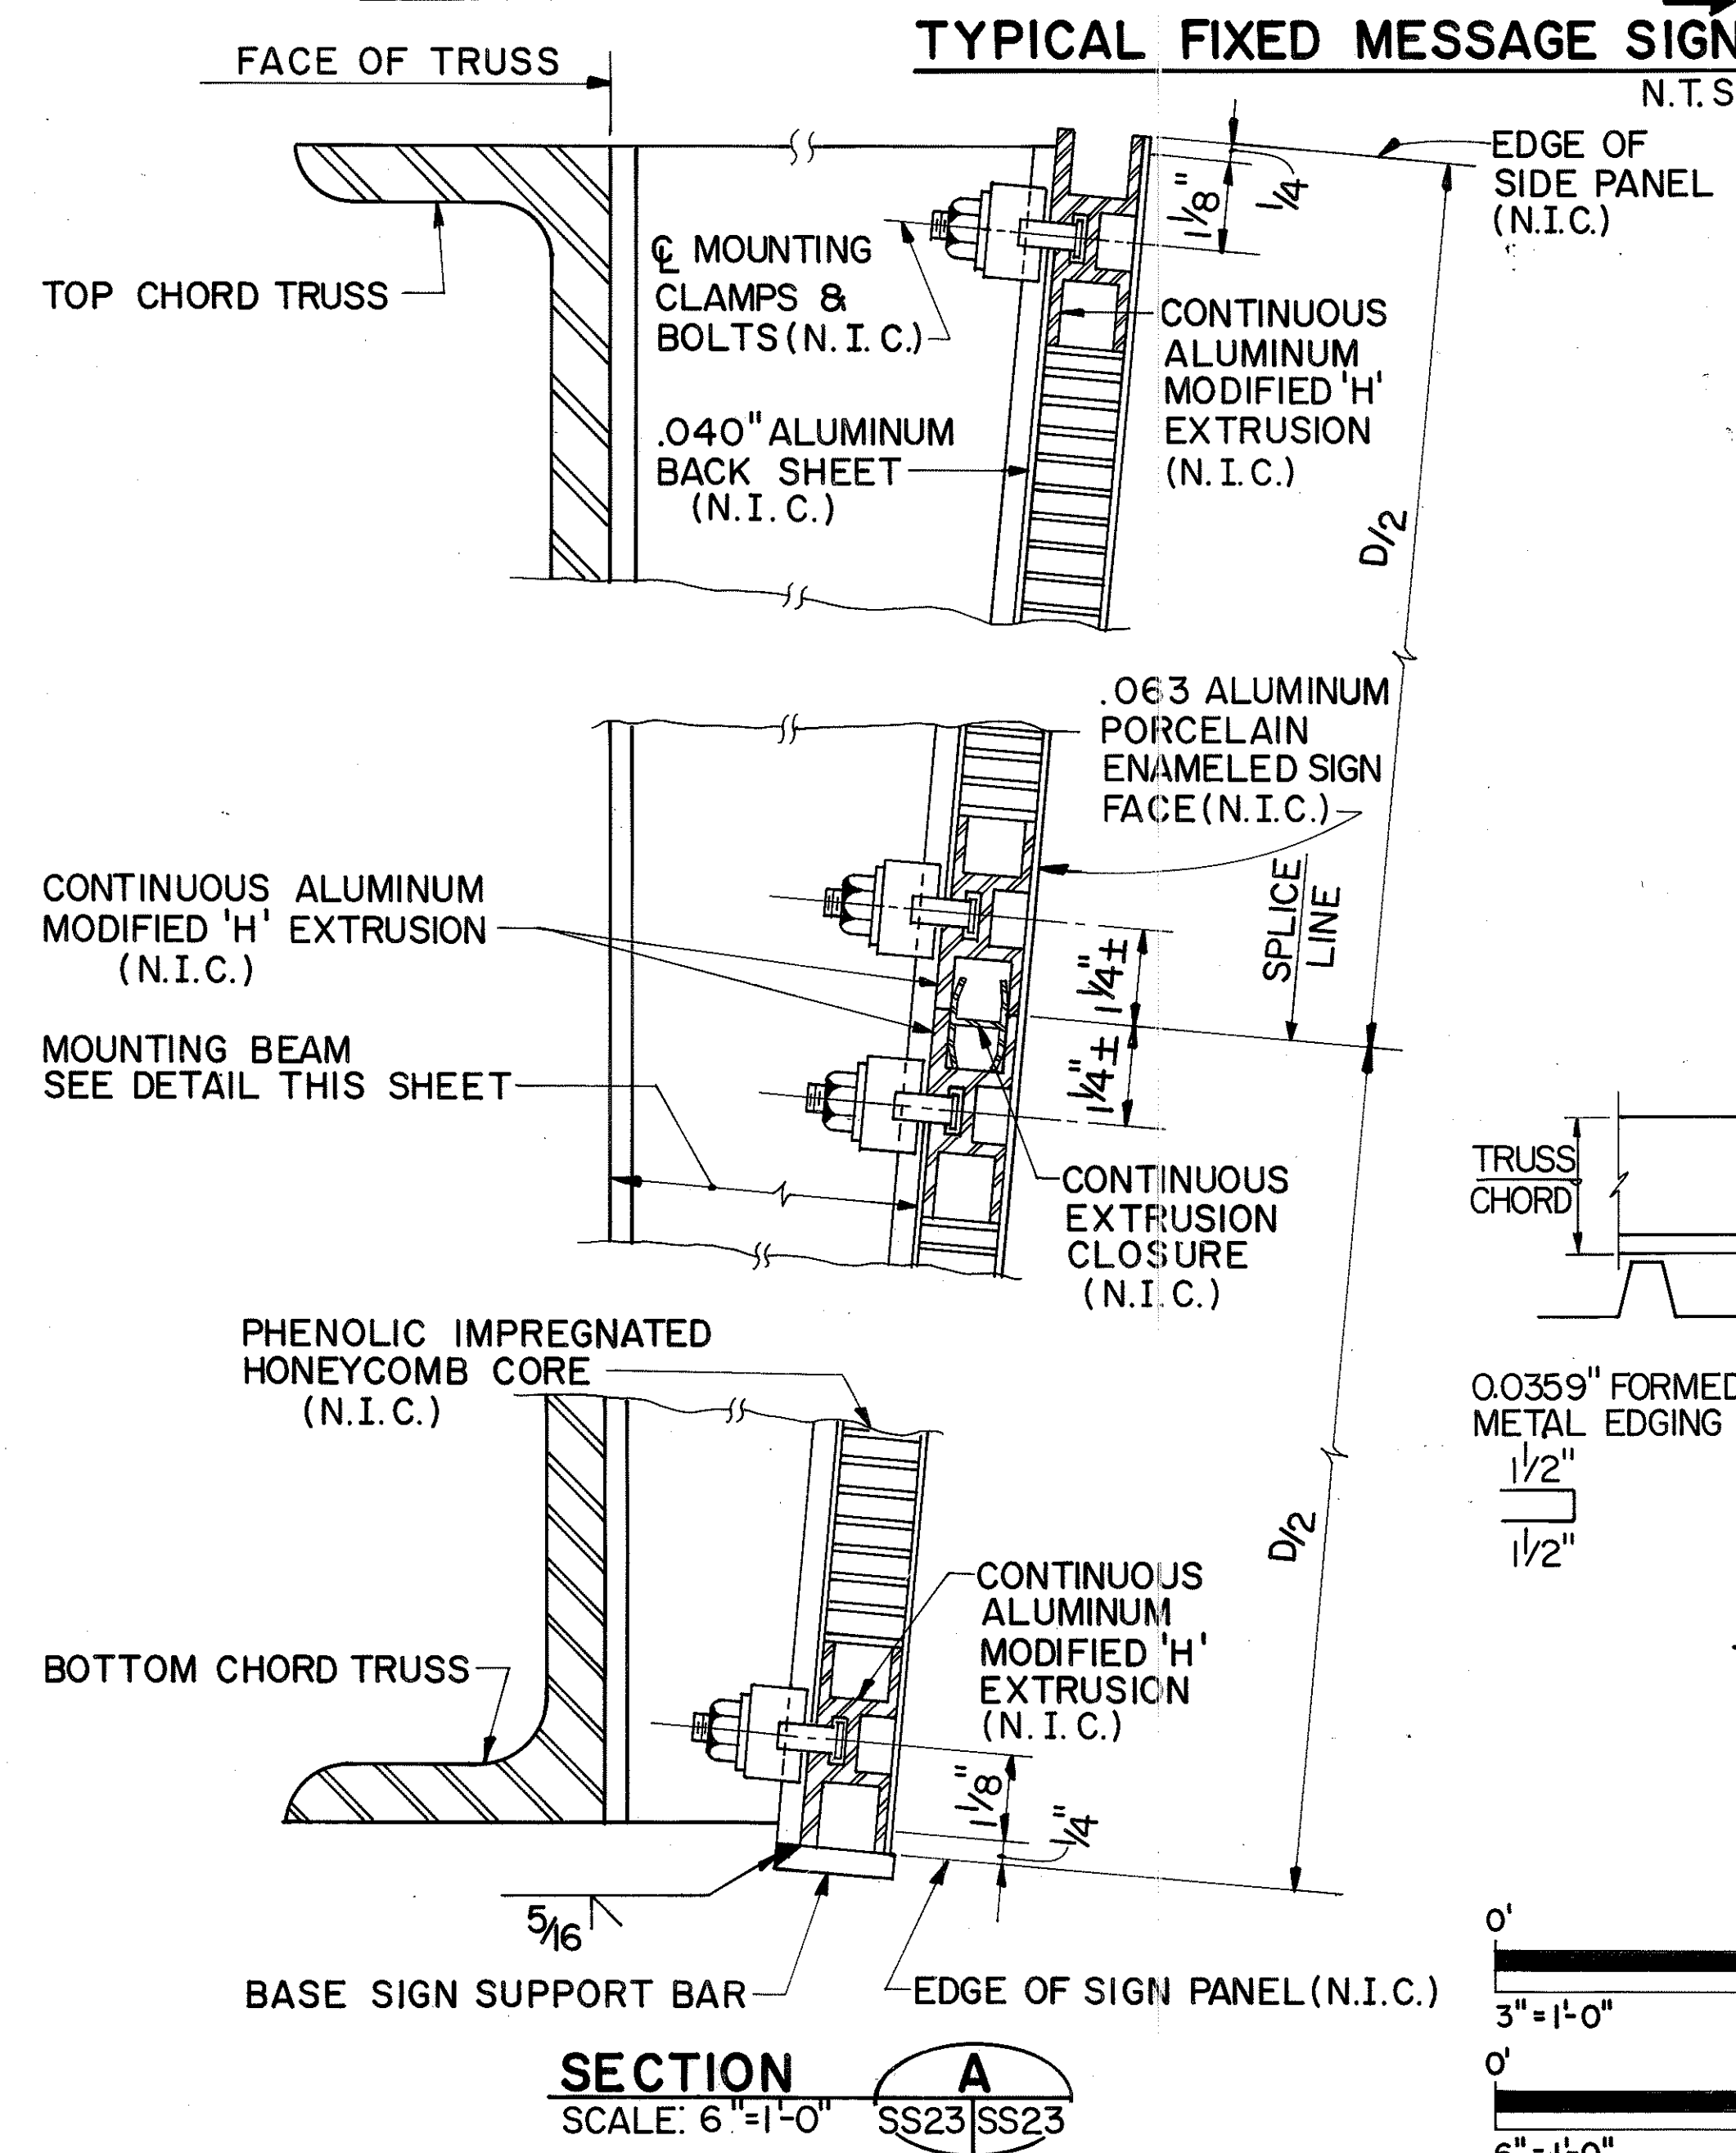

HUI PANG CHEN
 REGISTERED PROFESSIONAL ENGINEER
 No. 3865-S
 HAWAII, U.S.A.
 THIS WORK WAS PREPARED BY ME OR UNDER MY SUPERVISION.
Hui Pang Chen

2/24/94	REVISE SECTION DESIGNATION PER DCN 66-036
DATE	REVISION
STATE OF HAWAII DEPARTMENT OF TRANSPORTATION HIGHWAYS DIVISION FM SIGN CONNECTION DETAILS	
SUPPORT STRUCTURES INTERSTATE ROUTE H-3 F.A.I. PROJ. NO. I-H3-1 (66)	
SCALE: AS SHOWN	DATE: APR. 1992
SHEET No. SS23 OF 36 SHEETS	

VM SIGN (N.I.C.) = B (SEE NOTE 'A')

$B/10$ $B/5$ $B/5$ $B/5$ $B/5$ $B/10$

3'-9" 3'-9" 3"

3"

1 9/16" (TYP)

CL VM SIGN (N.I.C.)

A = 8'-0"

MOUNTING BOLT LOCATIONS (TYP) (N.I.C.)

MOUNTING BEAM (TYP)

1-3" Ø CONDUIT STUBS INTO BACK OF SIGN

SS24 SS24

SS24 SS24

LOCATIONS OF MOUNTING BEAMS

TYPICAL VARIABLE MESSAGE SIGN (VMS) ELEVATION

SCALE: 3/8" = 1'-0"

TOP CHORD TRUSS

MOUNTING BEAM
SEE DETAIL THIS SHEET

BOTTOM CHORD TRUSS

3"

4'-0"

3"

4'-0"

CL BOLTS (N.I.C.)

BOLTS WITH HEX NUT & WASHER (TYP) (N.I.C.)

CL BOLTS (N.I.C.)

CL BOLTS (N.I.C.)

TAPER BEAM & VM SIGN AS REQUIRED BY VM SIGN MANUFACTURER (N.I.C.)

SECTION A

SCALE: 3"=1'-0"

SS24/SS24

FACE OF TRUSS

SEAL WELD

TOP CHORD TRUSS

$\frac{1}{4}$ "

$6" \times 5\frac{5}{16}"$ PL CONTINUOUS

$\frac{5}{16}"$ WEB PL CONTINUOUS

$\frac{3}{16}$ "

$\frac{1}{4}$ "

BOTTOM CHORD TRUSS

$\frac{1}{4}$ "


SEAL WELD

4"

8'-0"

SECTION A
SCALE: 3"=1'-0"

SECTION **B**
SCALE: 3"=1'-0" SS24 SS24




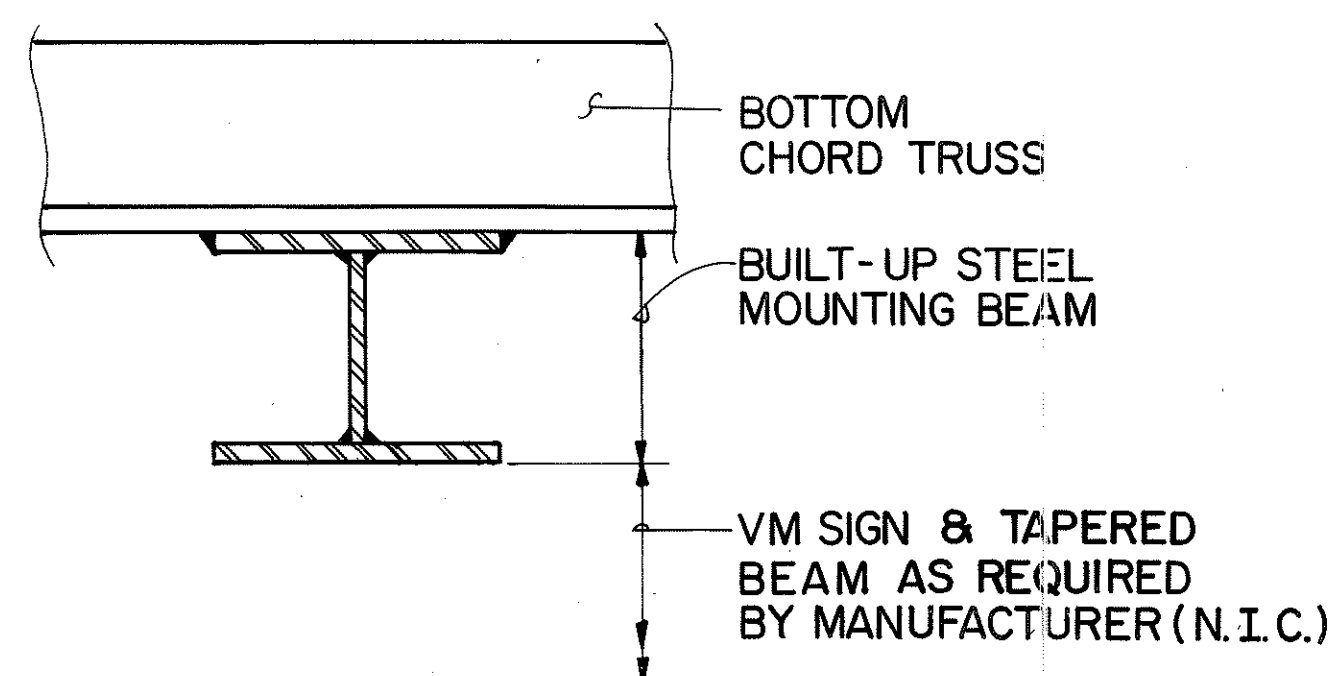


THIS WORK WAS PREPARED BY ME
OR UNDER MY SUPERVISION.

Shirong Chen

NOTES:

1. FOR TRUSS PANEL SPACING SEE SHEET NO. SS18.
2. FOR SIGN MOUNTING DETAILS, WALKWAY AND LUMINAIRE SUPPORT DETAILS, SEE SHEET NOS. SS23, SS24, SS27 & SS28.
3. ALL WALKWAY AND WALKWAY/ LUMINAIRE SUPPORTS ARE LOCATED AT TRUSS PANEL POINTS AS SHOWN.
4. WHEN THE LOCATION OF THE WALKWAY SUPPORT INTERFERES WITH THE BOTTOM WIND BRACINGS AT THE TRUSS PANEL POINT, THE WALKWAY SUPPORT SHALL BE RELOCATED. SEE OFFSET DETAILS ON THIS SHEET.

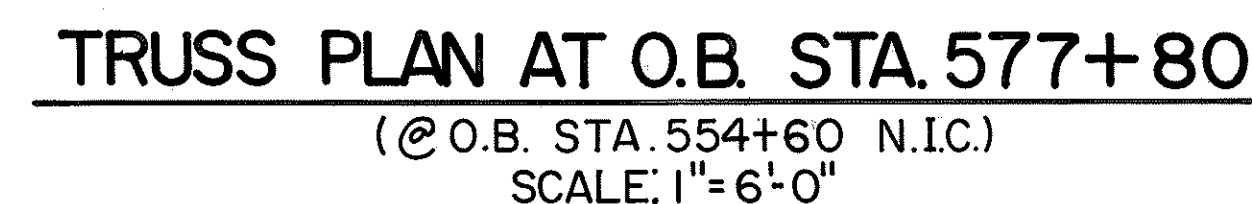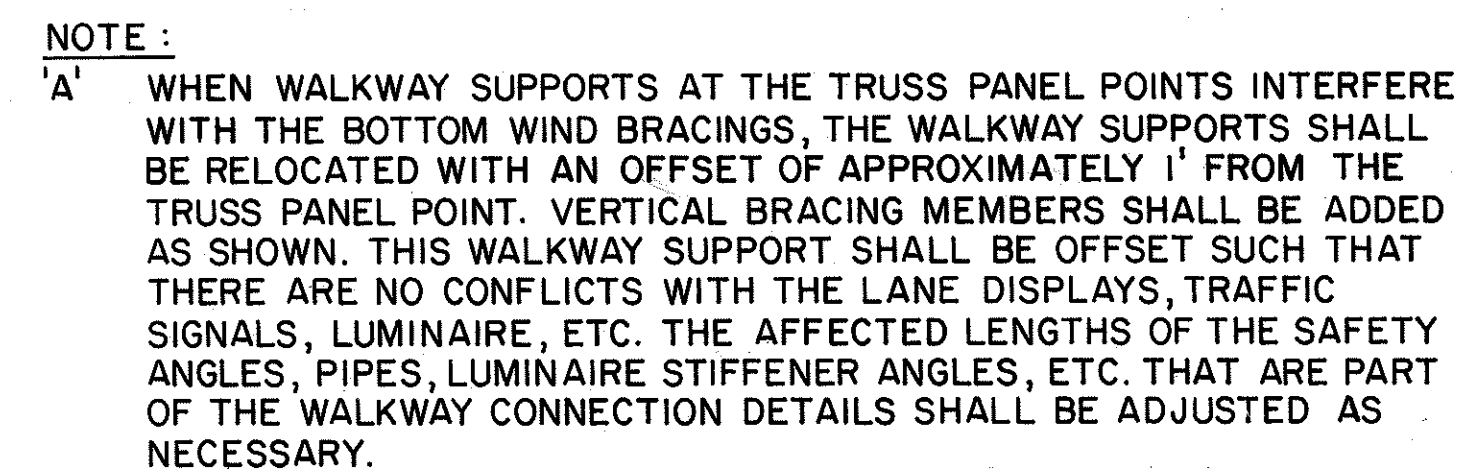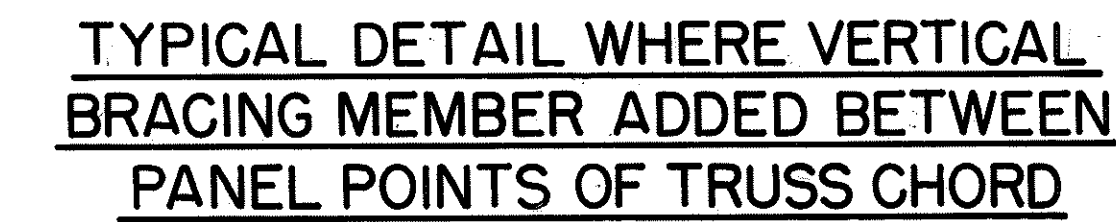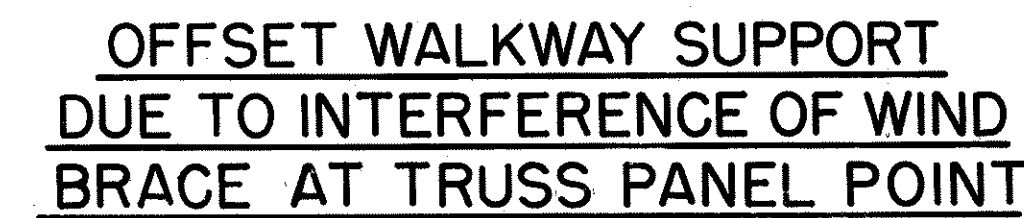


STATE OF HAWAII
DEPARTMENT OF TRANSPORTATION
HIGHWAYS DIVISION

HALAWA APPROACH -
WALKWAY PLANS
SUPPORT STRUCTURES
INTERSTATE ROUTE H-3
F.A.I. PROJ. NO. I-H3 - I (66)


SCALE: AS SHOWN DATE: APR. 1992

SHEET No. SS25 OF 36 SHEETS

THIS WORK WAS PREPARED BY ME
OR UNDER MY SUPERVISION.
Hsiangang Chen

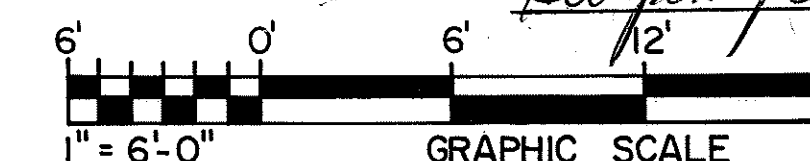

ORIGINAL PLAN	SURVEY PLOTTED BY	DATE
	DRAWN BY <u>K. MALALUMAN</u>	<u>1/90</u>
	TRACED BY	
NOTE BOOK	DESIGNED BY <u>K. WADA</u>	<u>1/90</u>
	QUANTITIES BY <u>S. CHUN</u>	<u>3/90</u>
No.	CHECKED BY <u>S. CHUN</u>	<u>1/90</u>

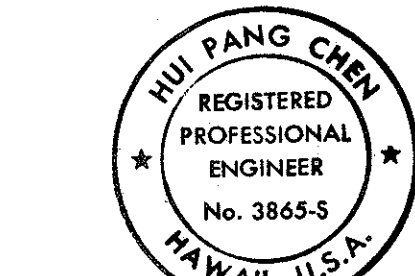

Hirang Chen

DATE	REVISION











STATE OF HAWAII
DEPARTMENT OF TRANSPORTATION
HIGHWAYS DIVISION

HAIKU APPROACH -
WALKWAY PLANS
SUPPORT STRUCTURES
INTERSTATE ROUTE H-3
F.A.I. PROJ. NO. I-H3-1 (66)

SCALE: 1" = 6'-0" DATE: APR. 1992

SHEET NO. SS26 OF 36 SHEETS

FED. ROAD DIST. NO.	STATE	FED. AID PROJ. NO.	FISCAL YEAR	SHEET NO.	TOTAL SHEETS
HAWAII	HAW.	I-H3-1(66)	1992	389	440

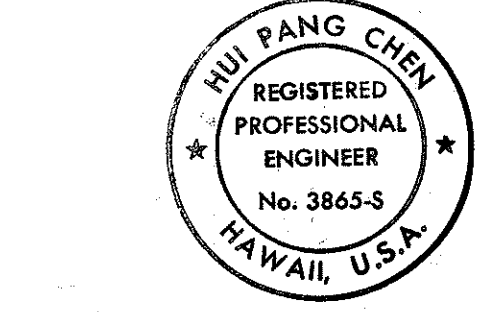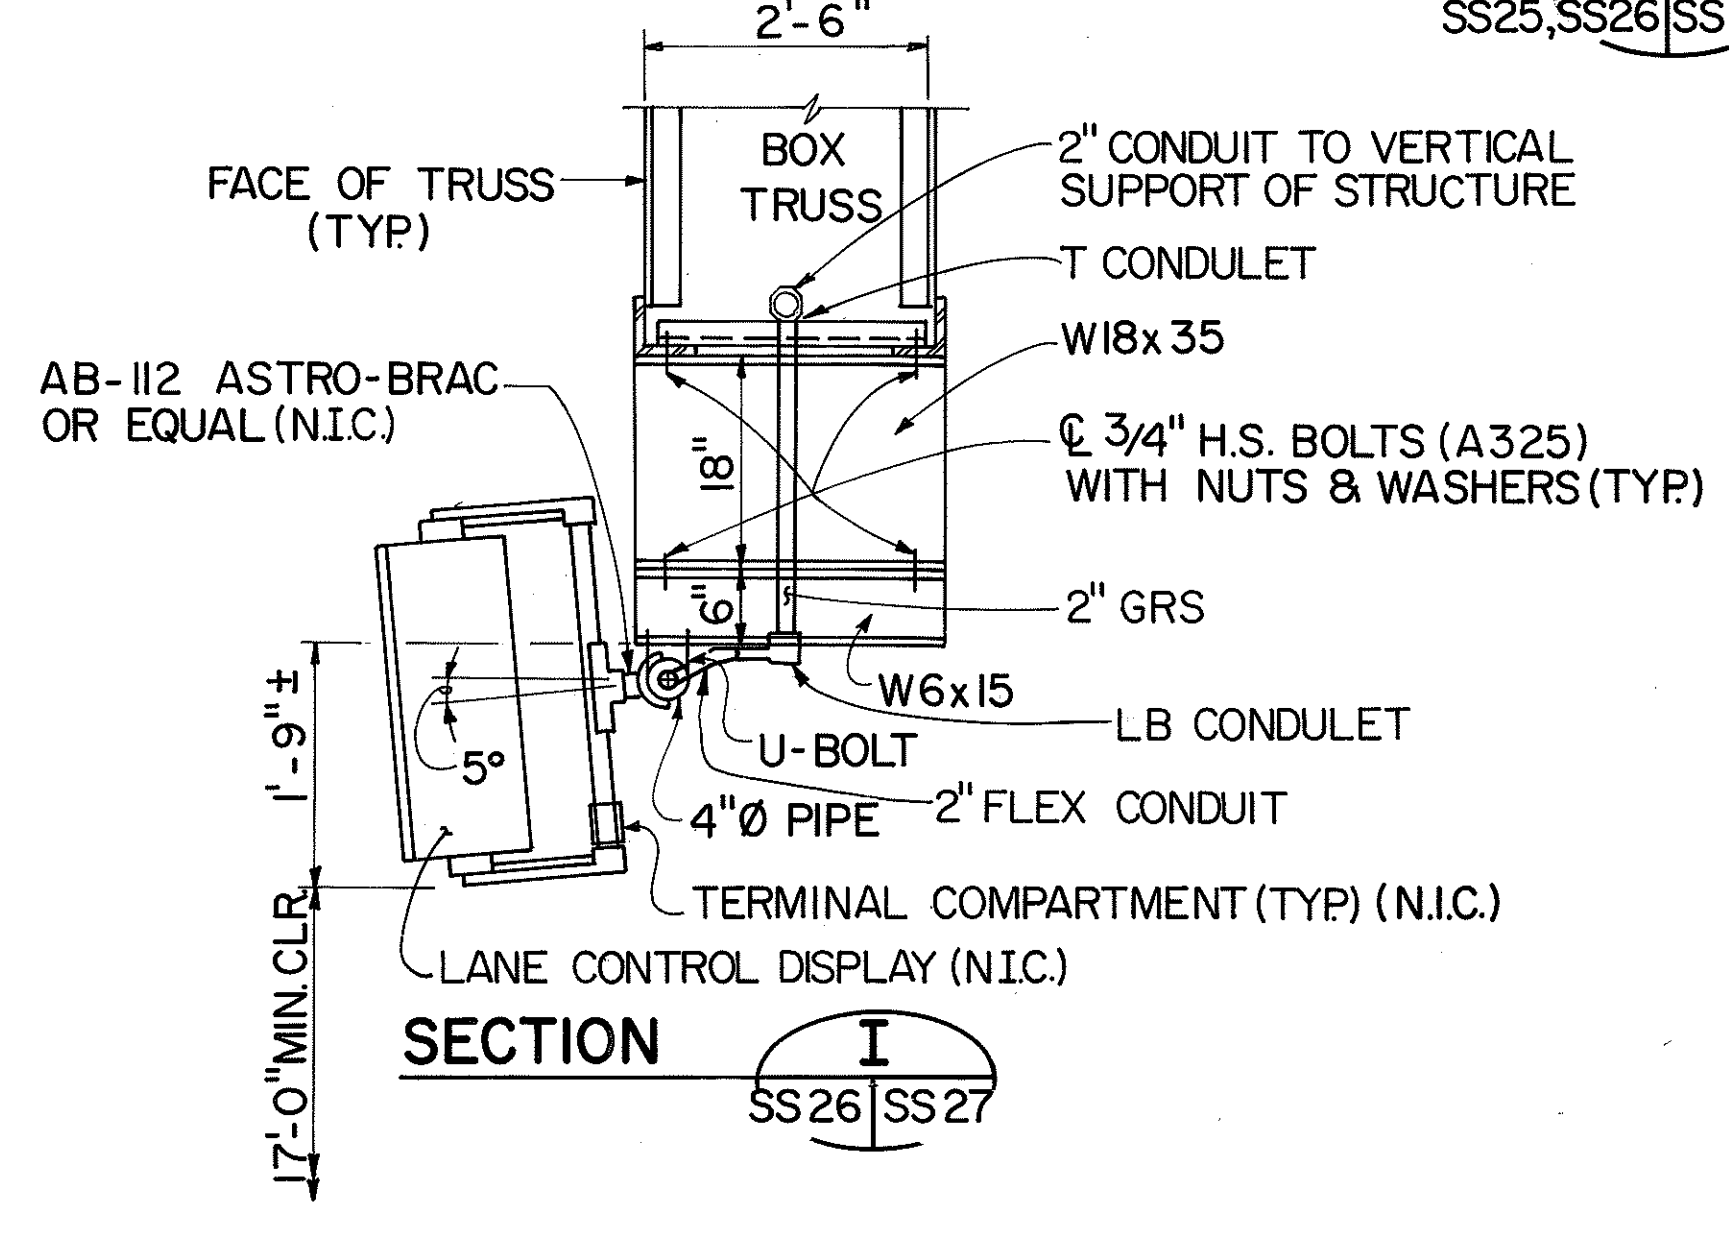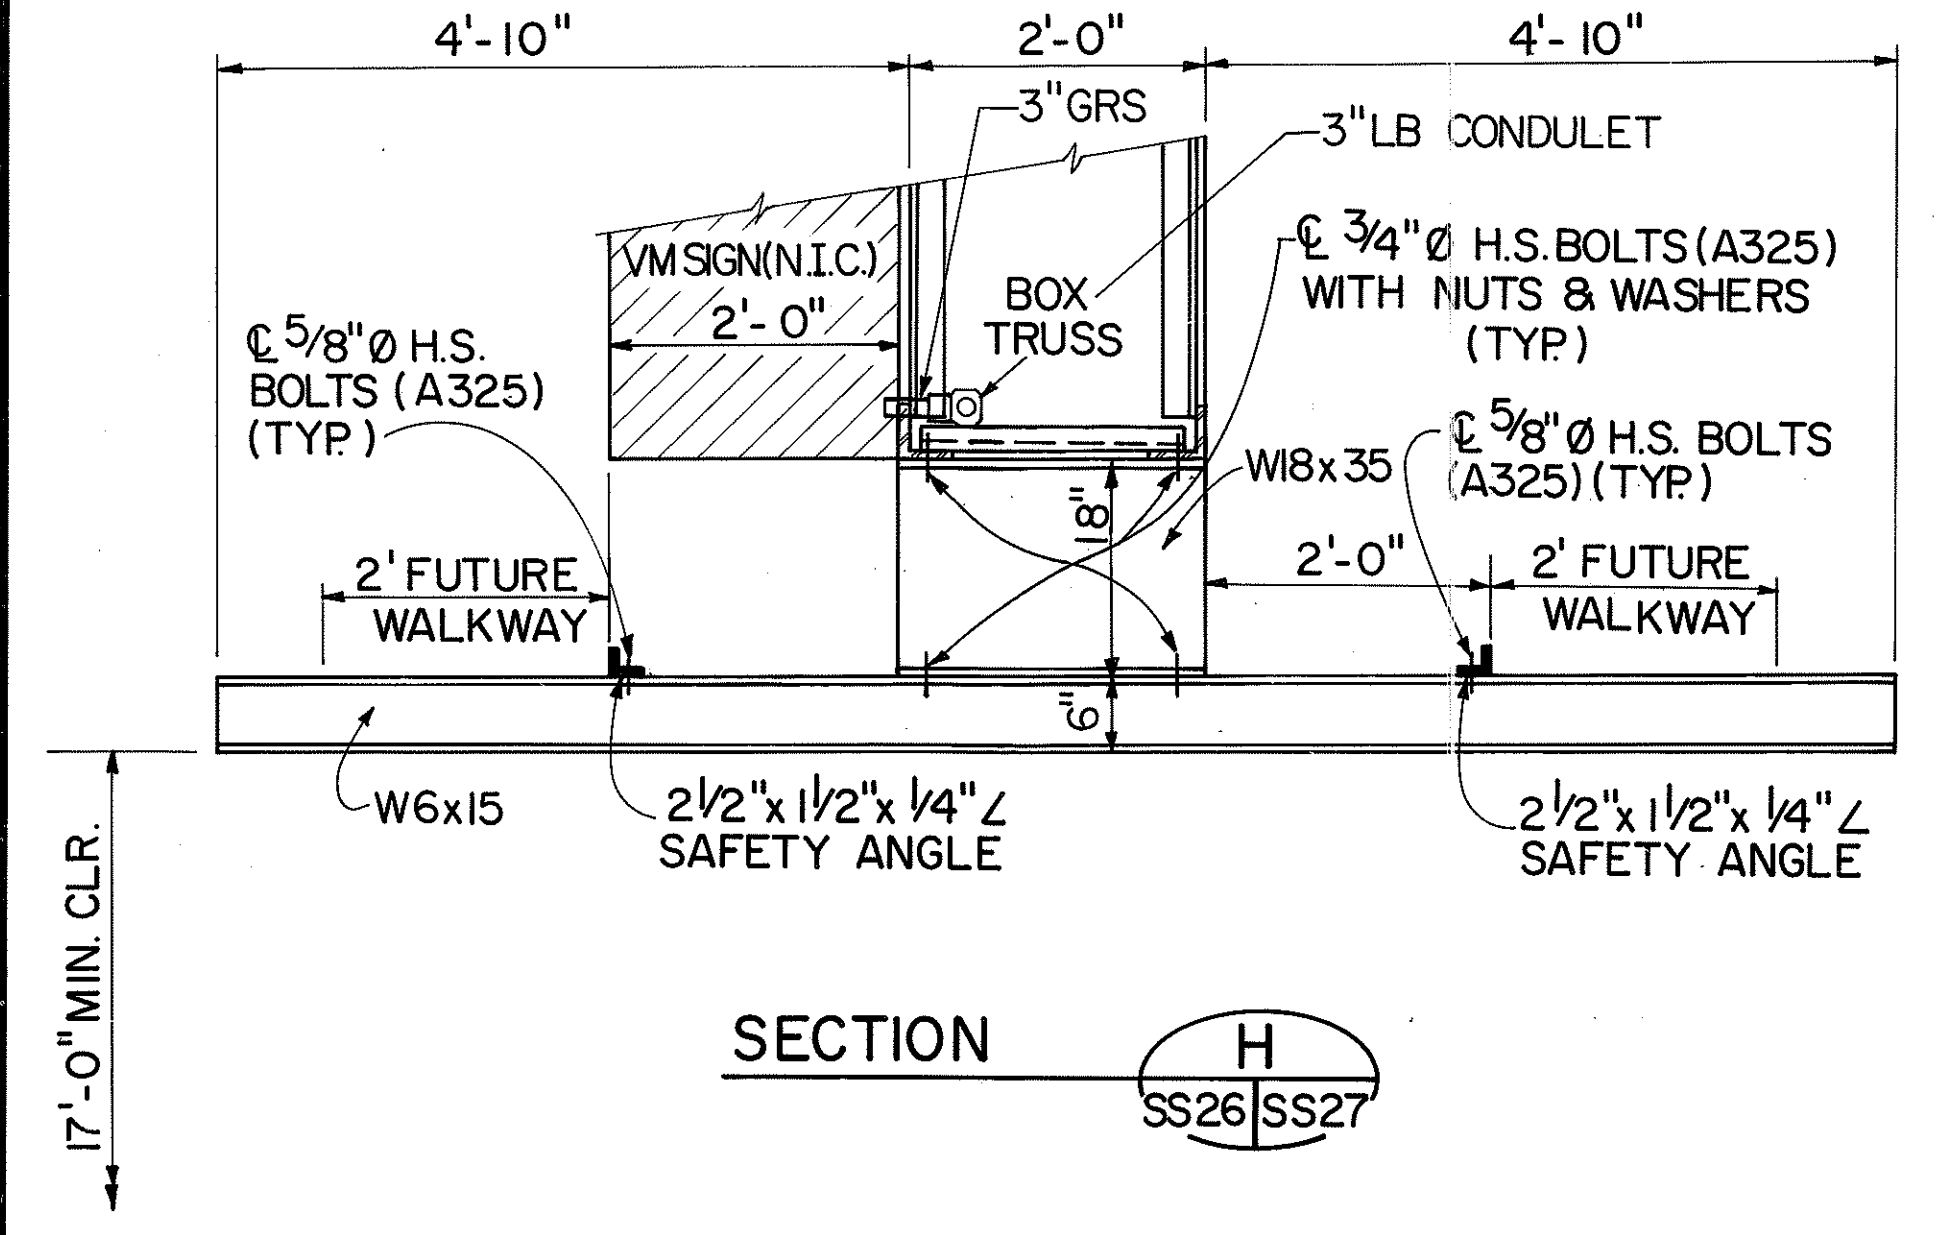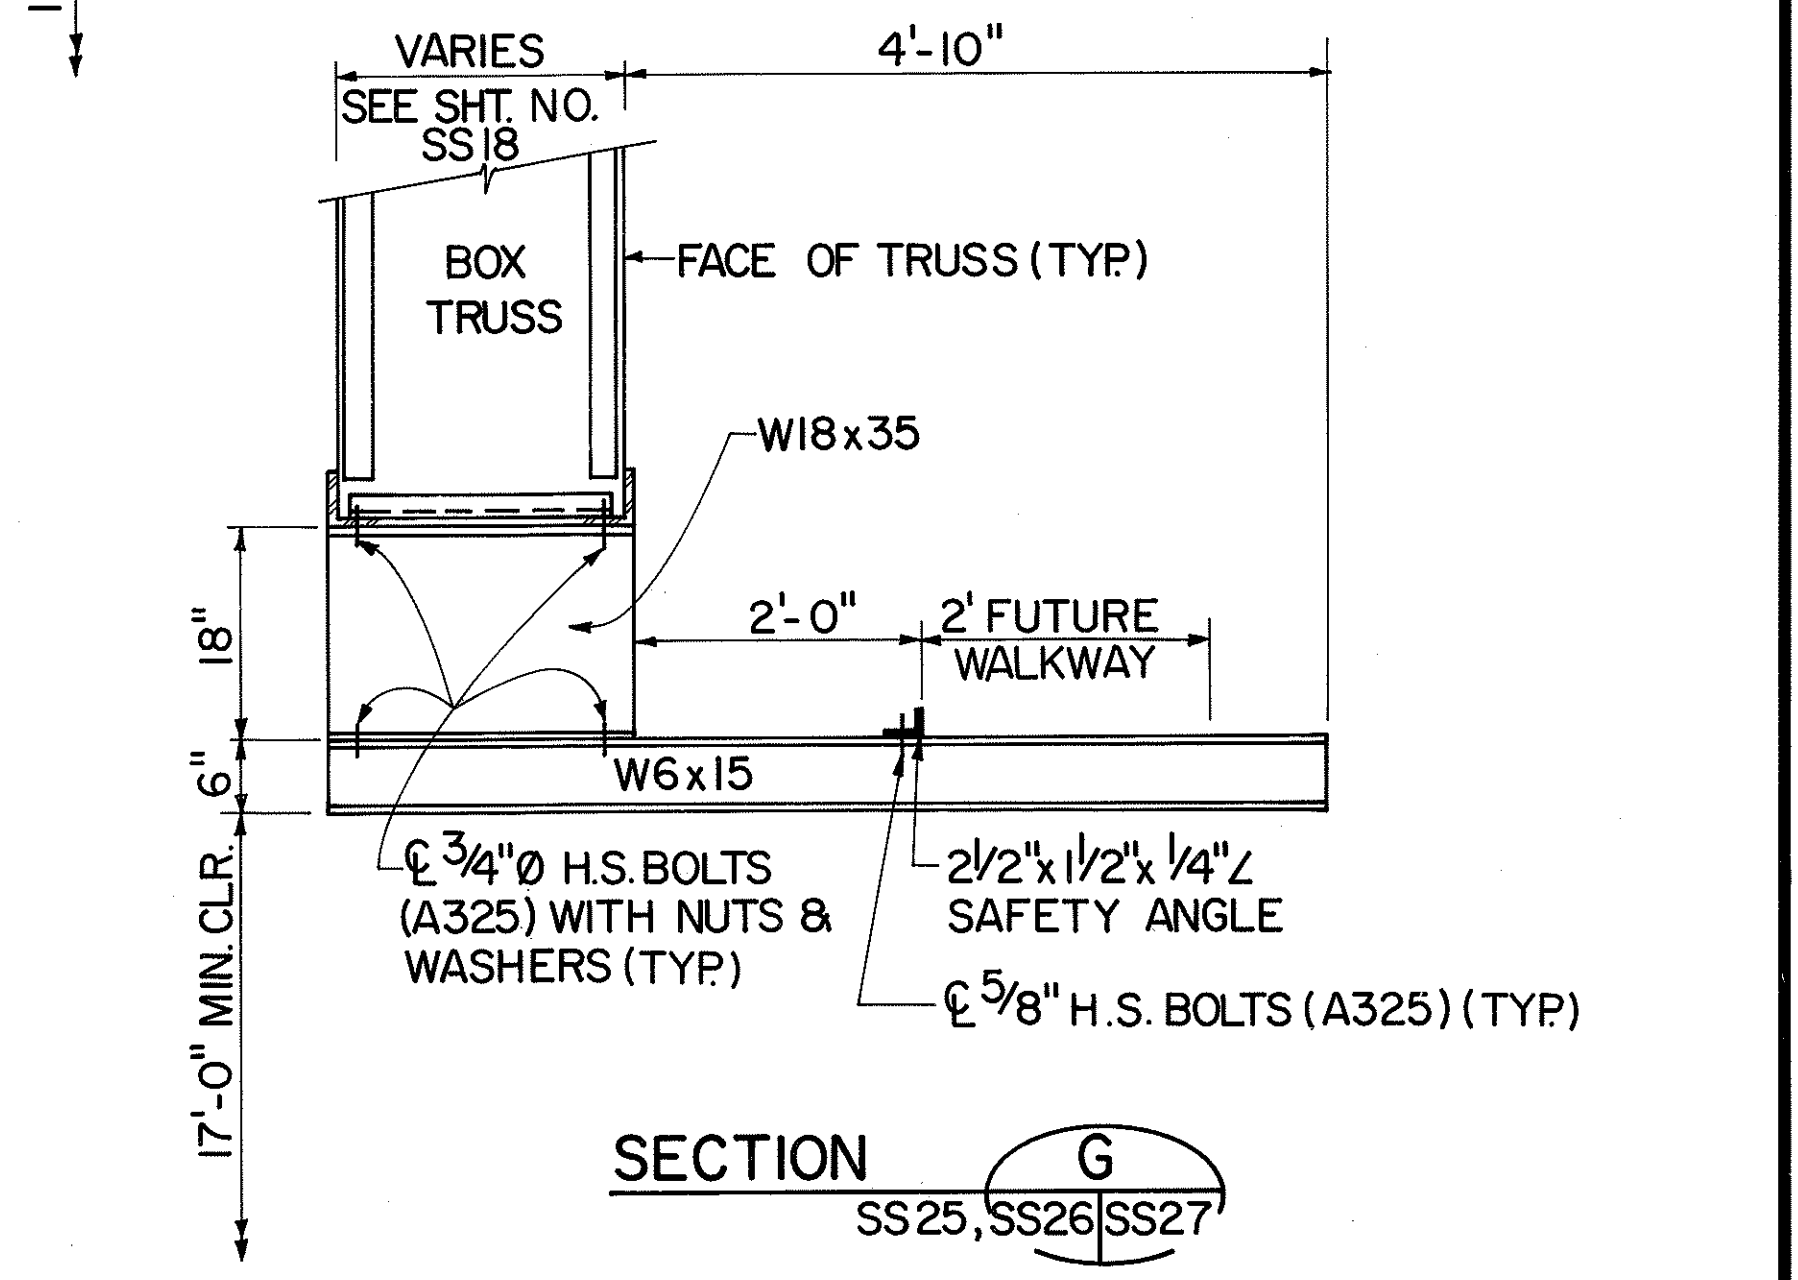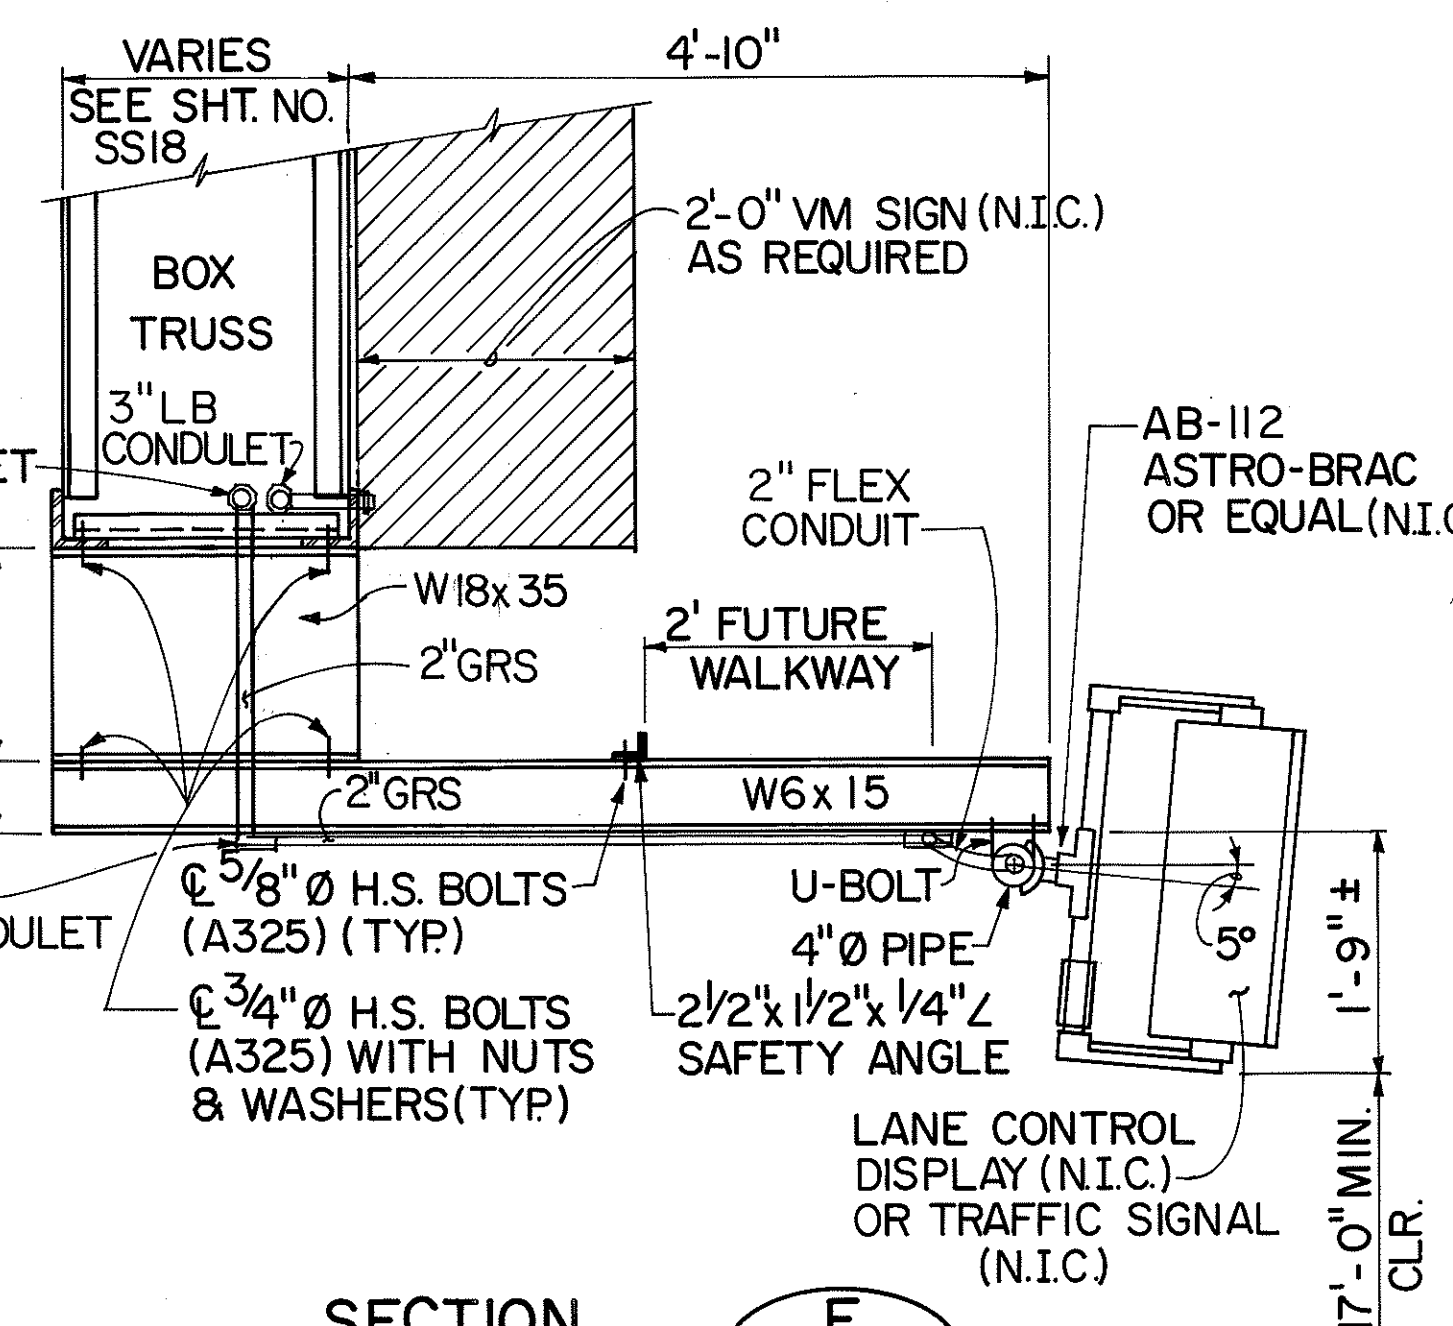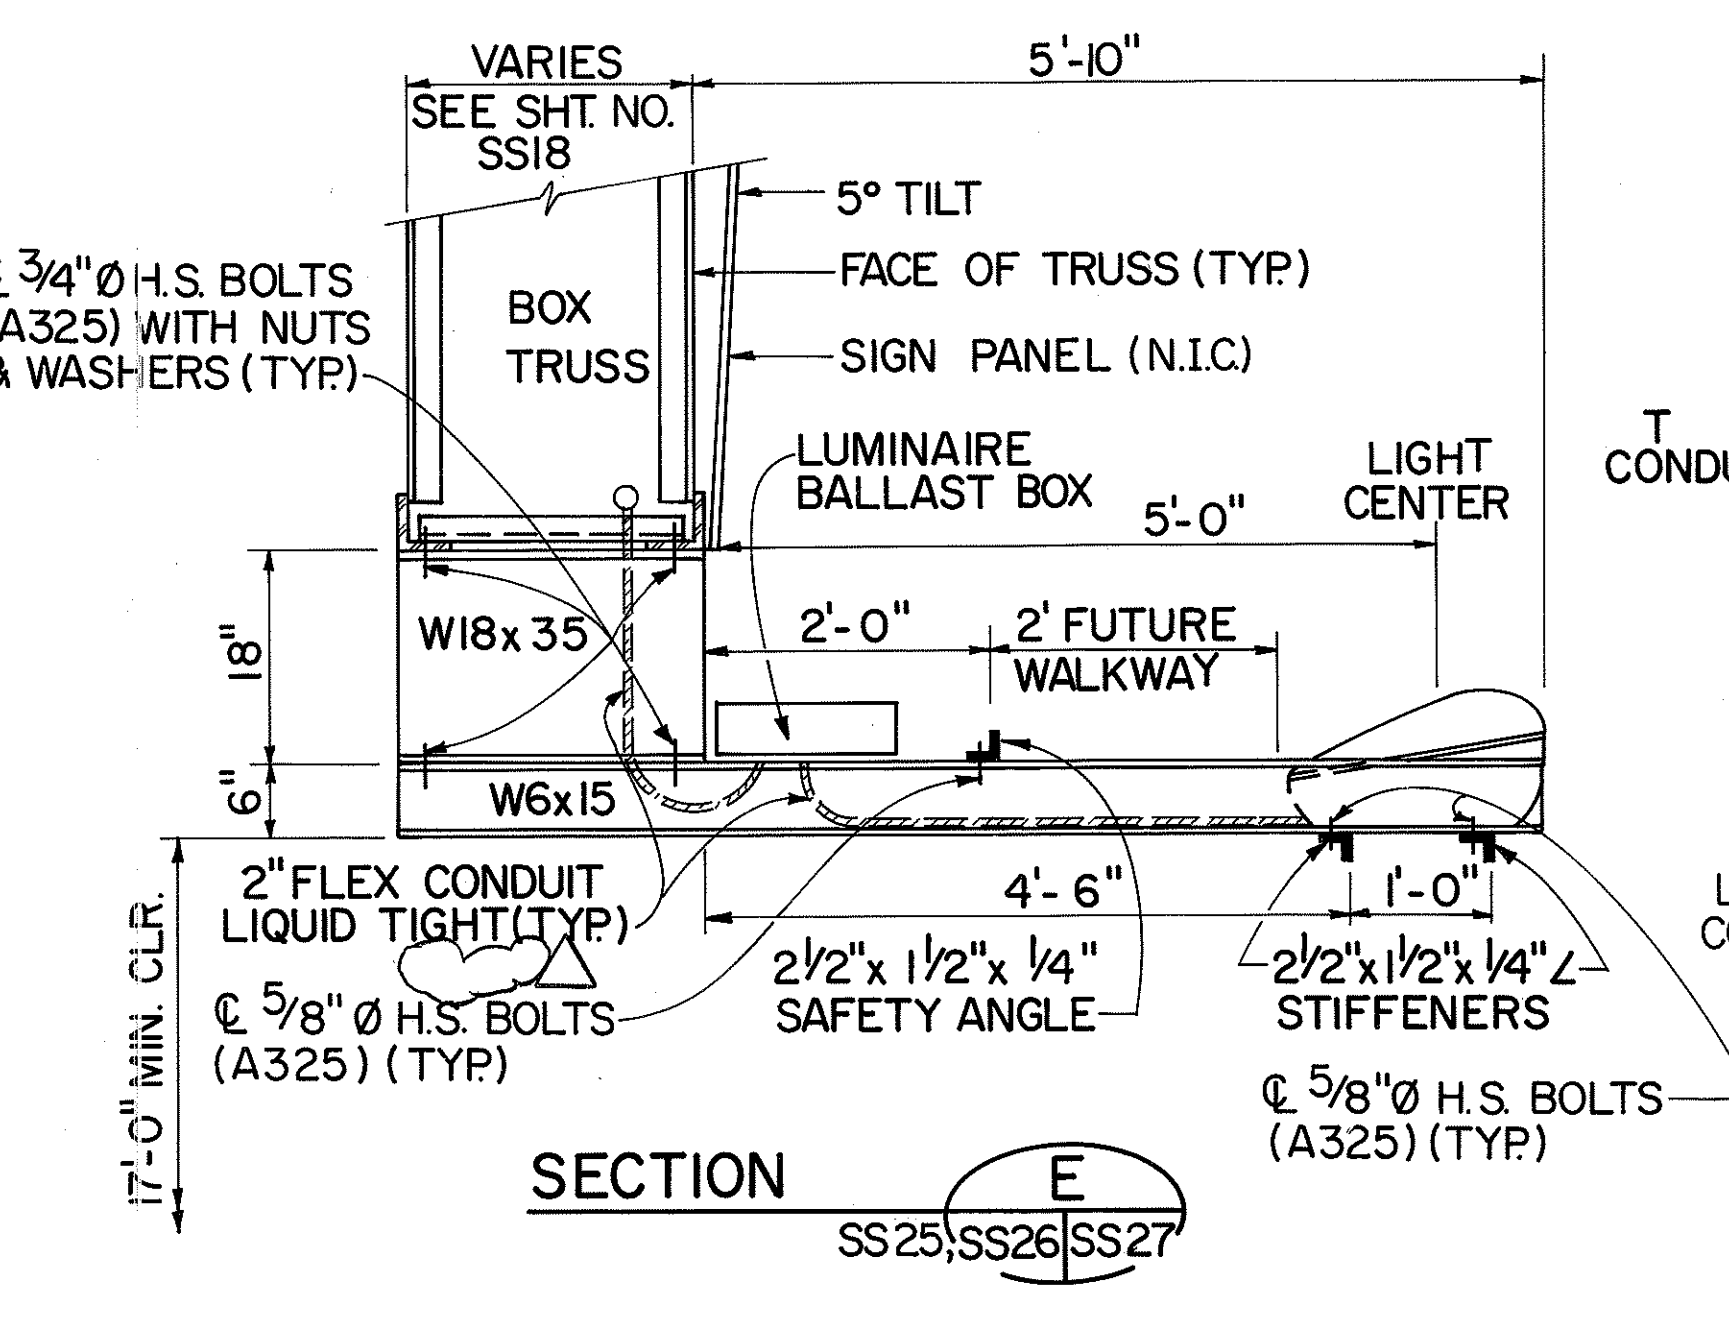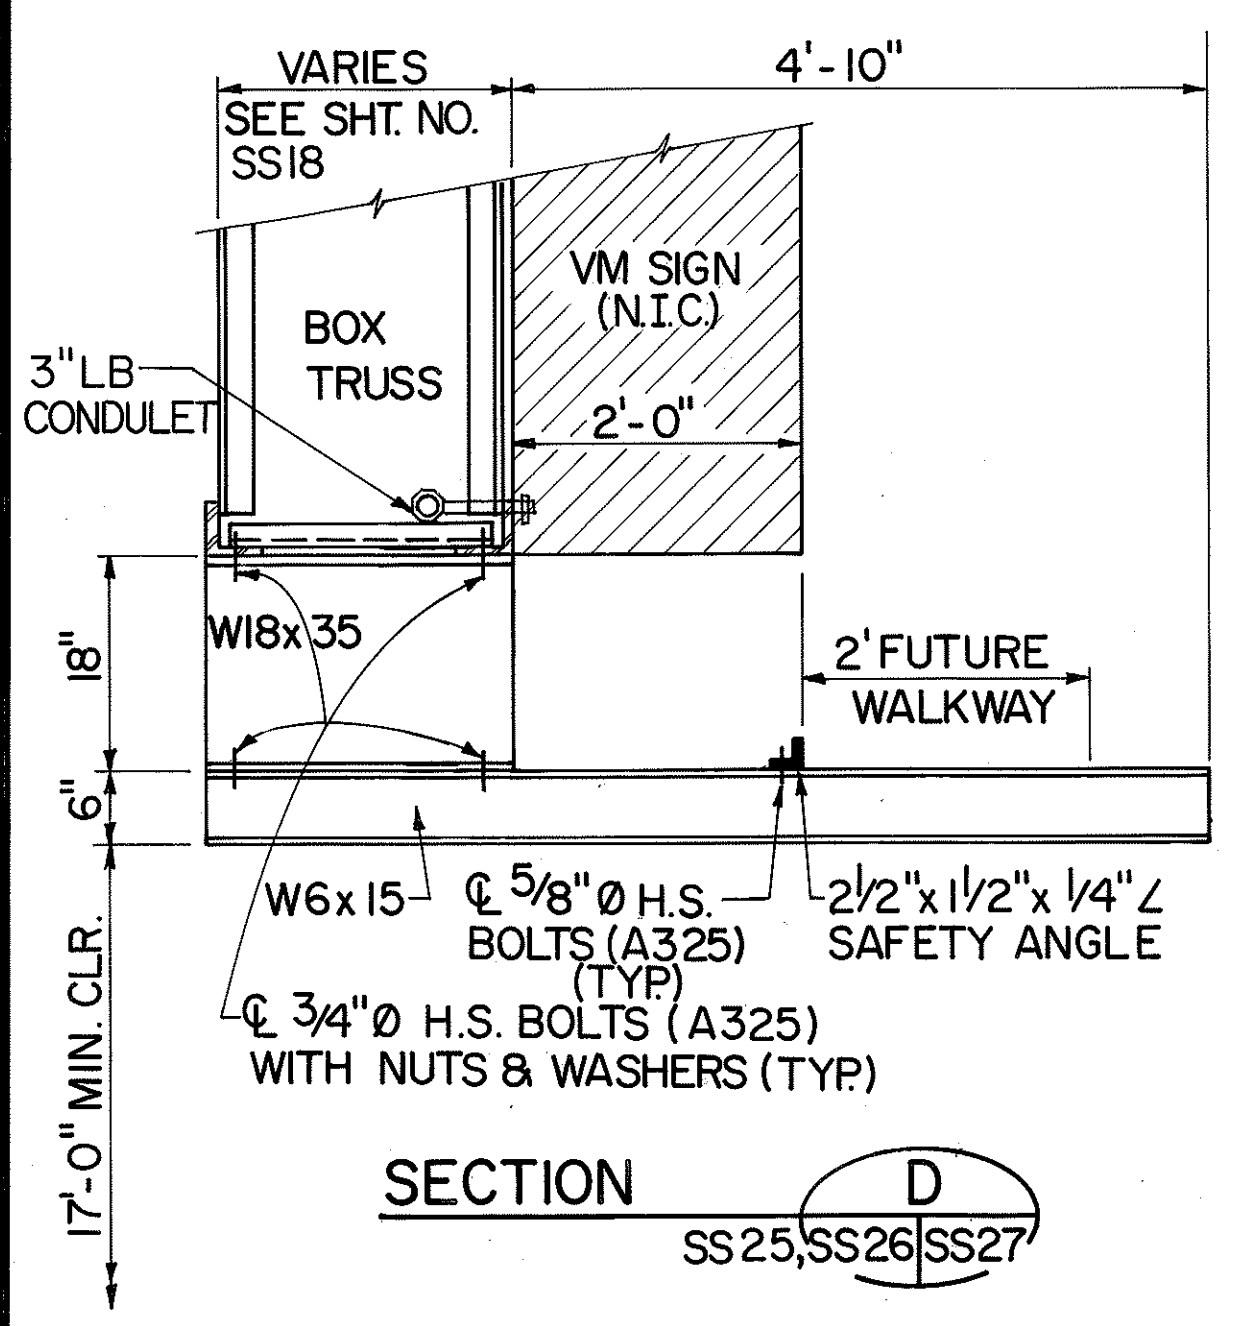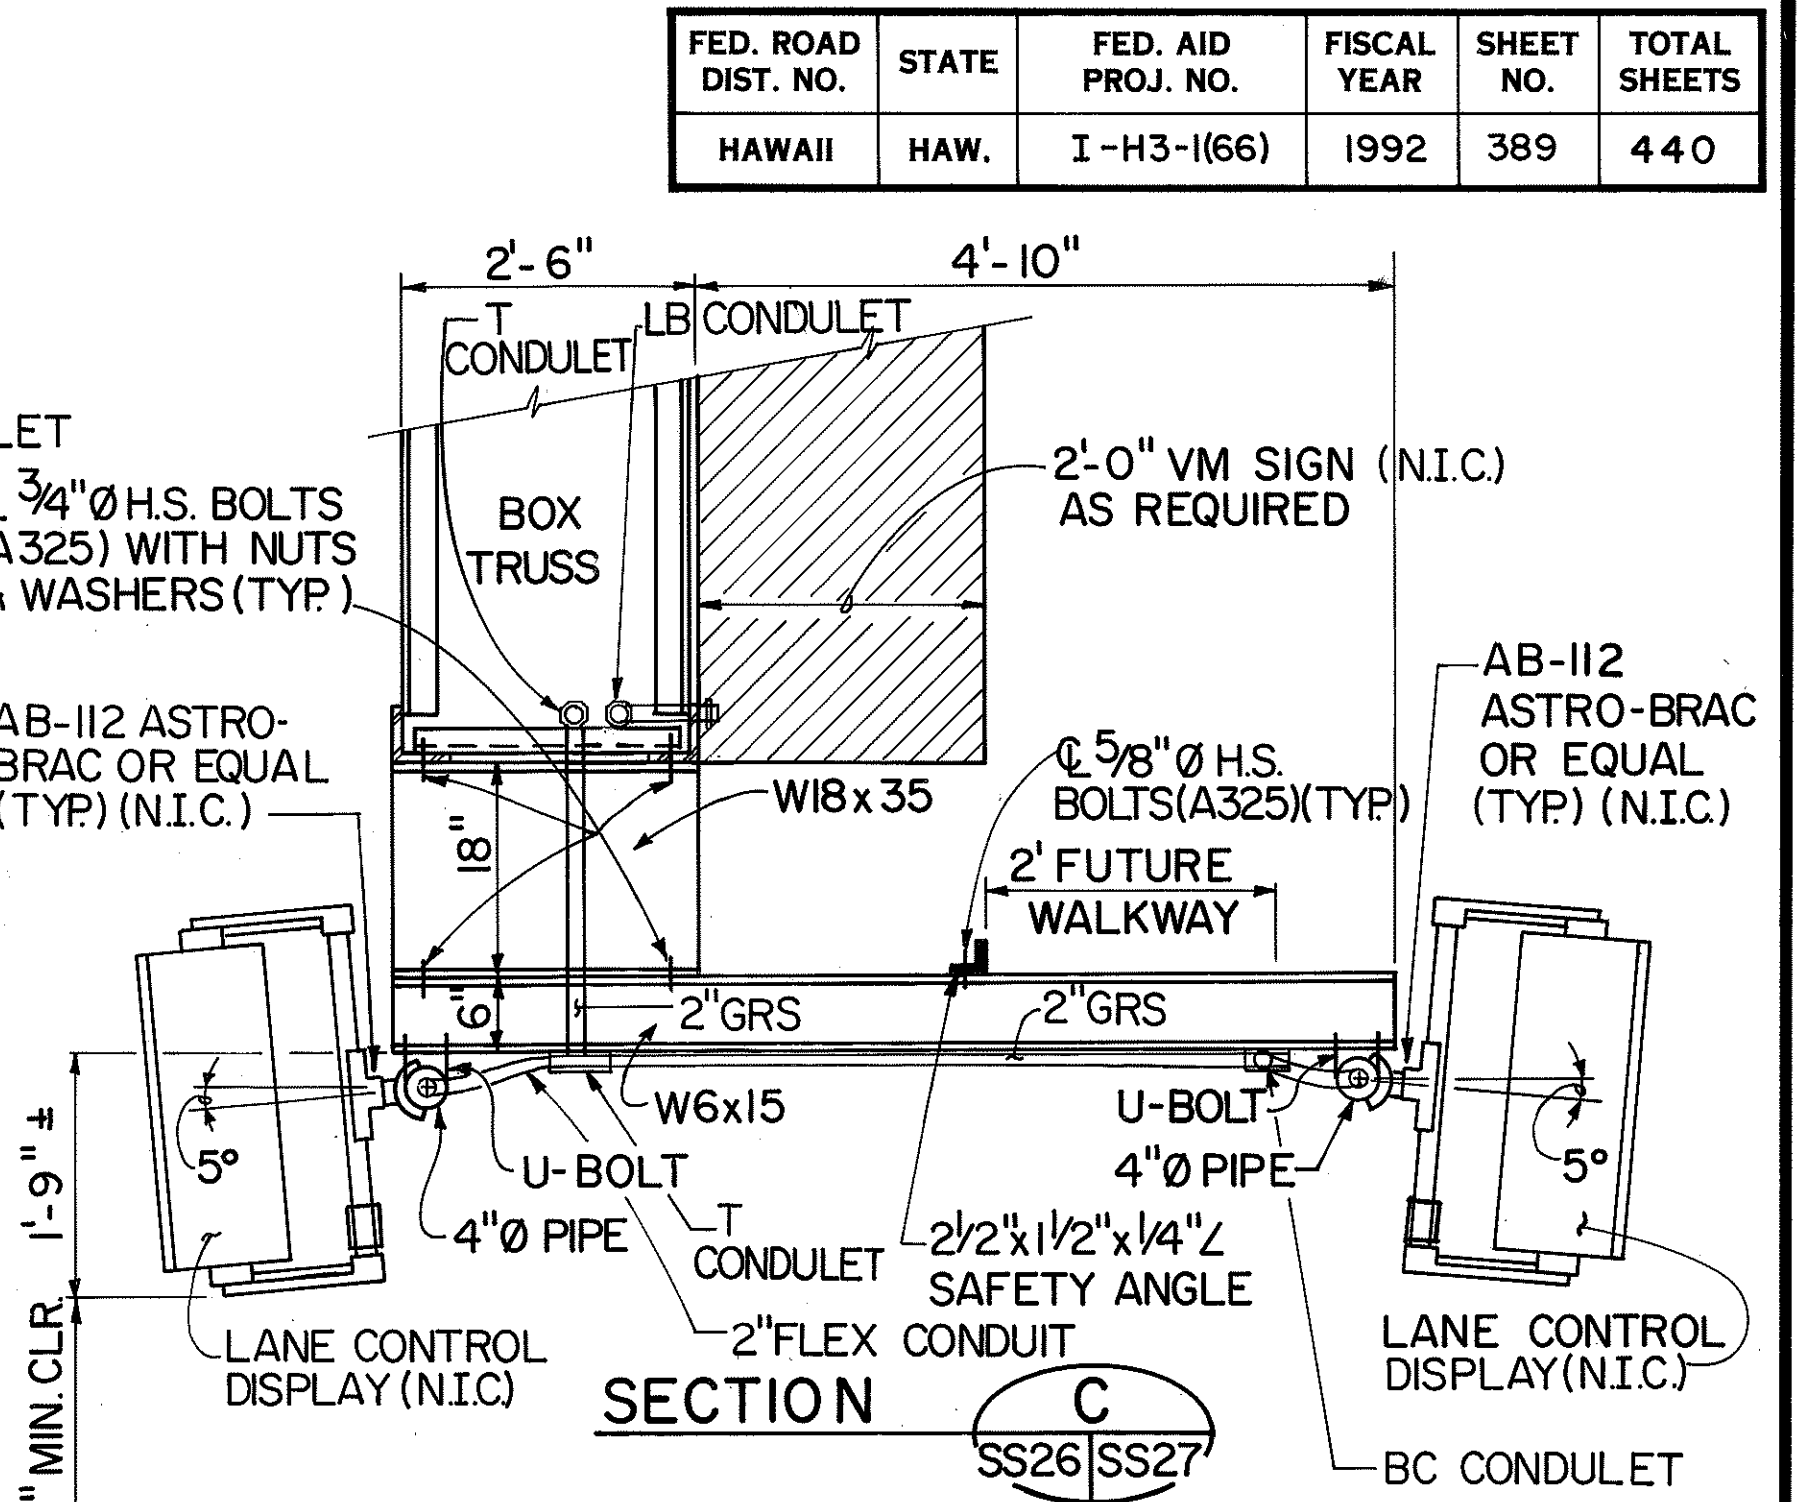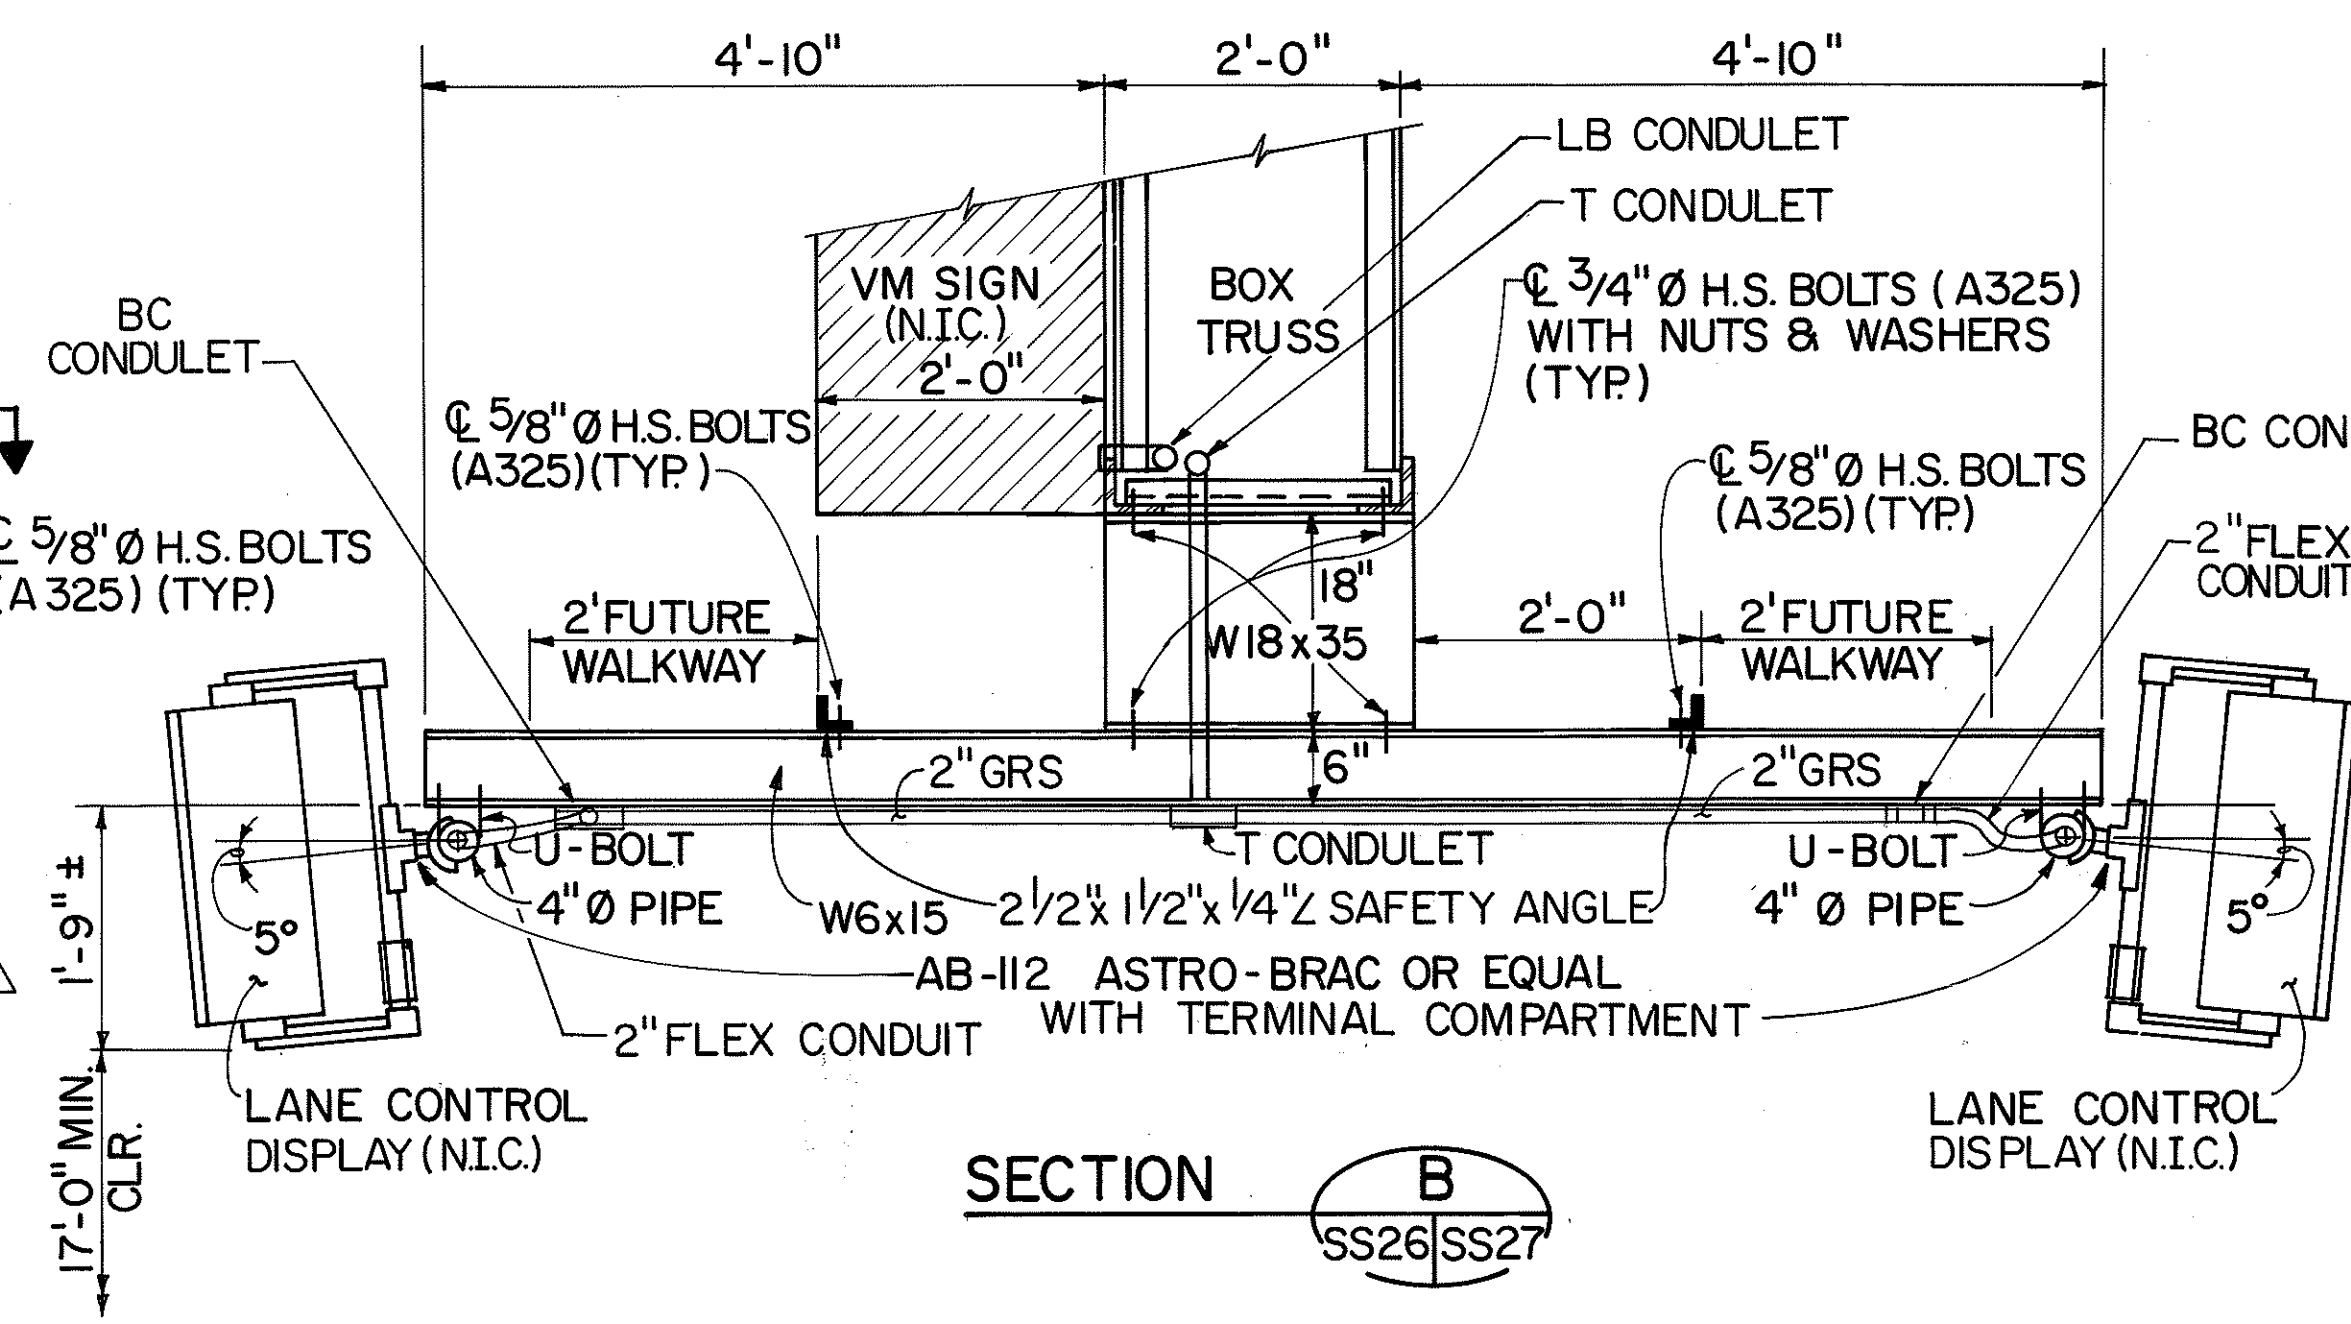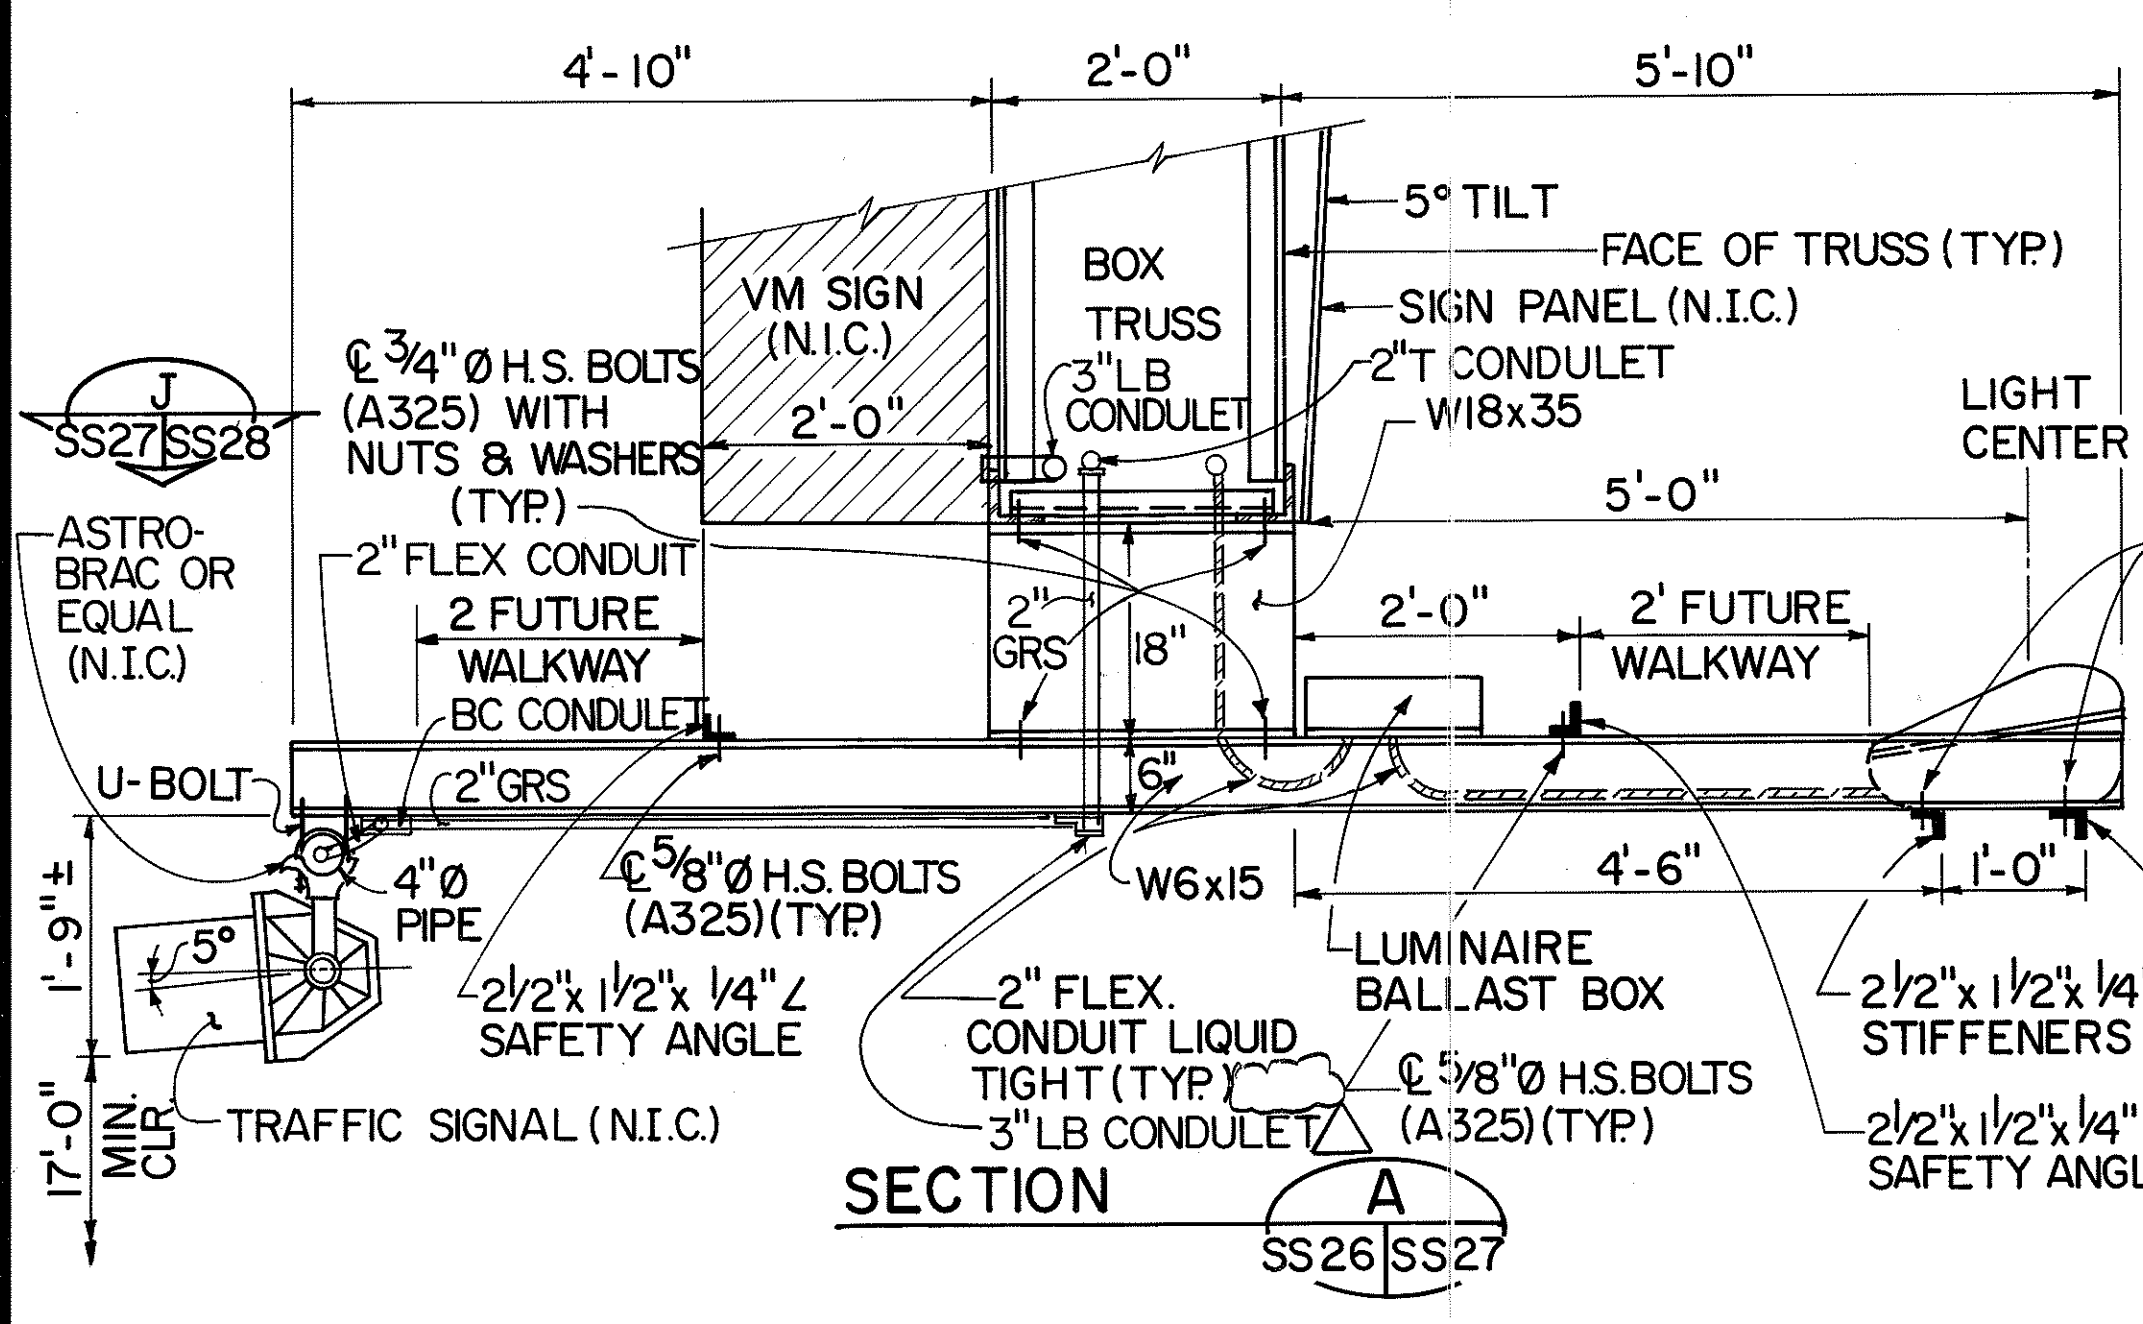

THIS WORK WAS PREPARED BY ME OR UNDER MY SUPERVISION.
Hui Pang Chen








7/20/93	DELETED (N.I.C.) FROM FLEX CONDUIT PER DCN 66-014
DATE	REVISION
STATE OF HAWAII DEPARTMENT OF TRANSPORTATION HIGHWAYS DIVISION	
WALKWAY DETAILS - I	
SUPPORT STRUCTURES INTERSTATE ROUTE H-3 F.A.I. PROJ. NO. I-H3-1 (66)	
SCALE: 3/4"=1'-0"	DATE: APR. 1992
SHEET No. SS27 OF 36 SHEETS	



SURVEY PLOTTED BY	DATE
DRAWN BY	1/92
DESIGNED BY	1/92
QUANTITIES BY	1/92
CHECKED BY	1/92

FED. ROAD DIST. NO.	STATE	FED. AID PROJ. NO.	FISCAL YEAR	SHEET NO.	TOTAL SHEETS
HAWAII	HAW.	I-H3-1(66)	1992	390	440

- NOTES:
- FOR GENERAL NOTES SEE SHEET NO. SS1
 - LOCATIONS OF SIGN LUMINAIRES AND WALKWAY BRACKETS MAY BE ADJUSTED TO AVOID ANY INTERFERENCE WITH BOTTOM WIND BRACING SUBJECT TO THE APPROVAL OF THE ENGINEER.
 - LOAD OF WALKWAY AND RAILING ON EACH BRACKET SHALL NOT EXCEED 375 LBS.
 - LIVE LOAD ON EACH BRACKET = 500 LBS.
 - FOR LOCATIONS OF SIGN LUMINAIRES AND WALKWAY BRACKETS, SEE SHEET NOS. SS25 & SS26
 - ALL STRUCTURAL STEEL, STEEL PIPE, STEEL STRAP, CONNECTION BOLTS, WASHERS & NUTS IN WALKWAY/LUMINAIRE SUPPORTS SHALL BE HOT DIP GALVANIZED AFTER FABRICATION.
 - VARIABLE MESSAGE SIGNS (VMS), TRAFFIC SIGNALS AND LANE CONTROL DISPLAYS ARE SHOWN FOR INFORMATIONAL PURPOSES ONLY. THESE UNITS ARE TO BE PROVIDED AND INSTALLED BY OTHERS.

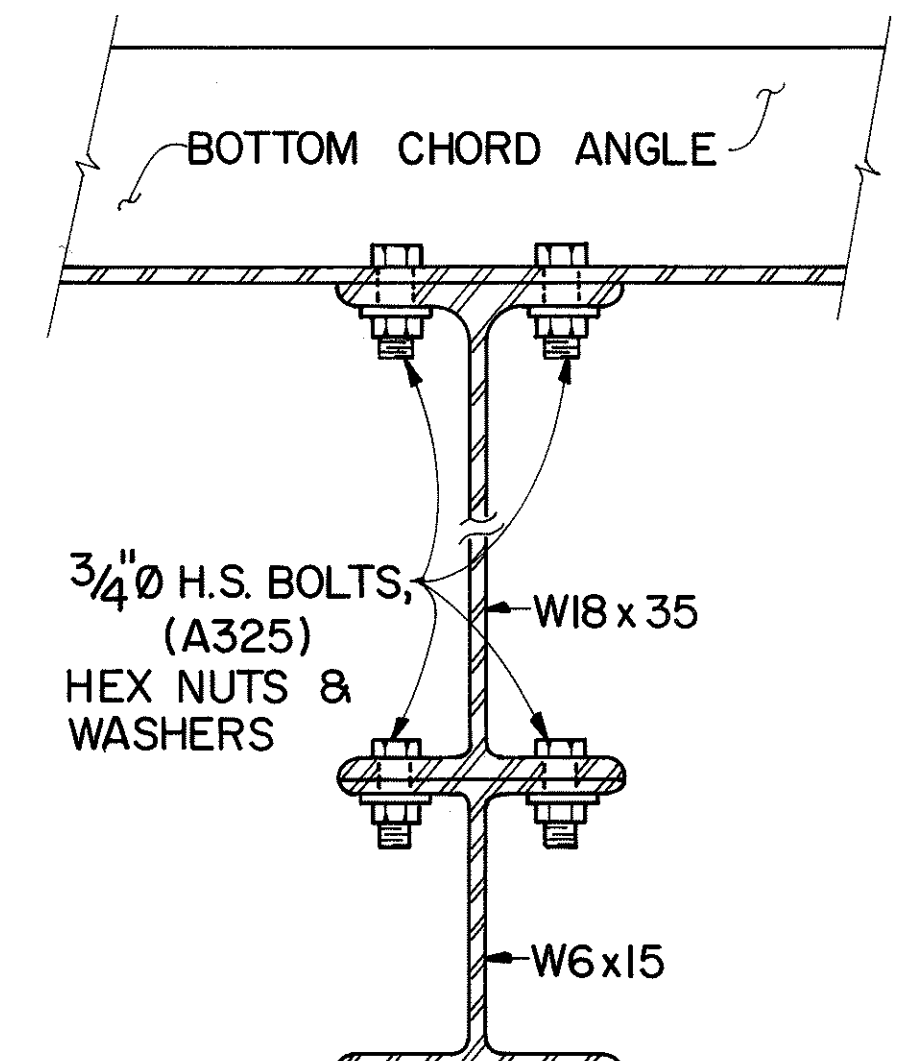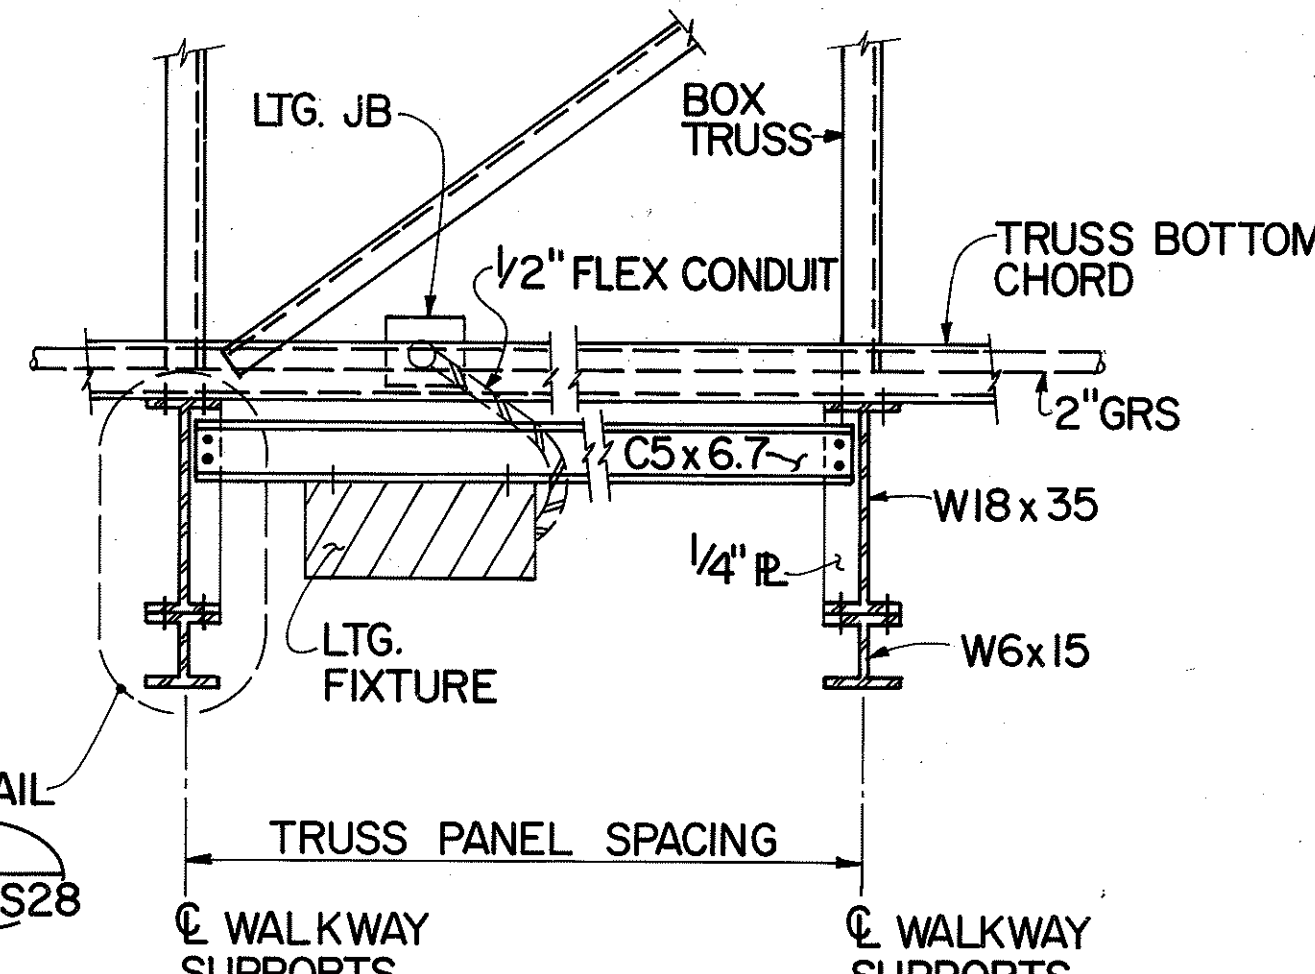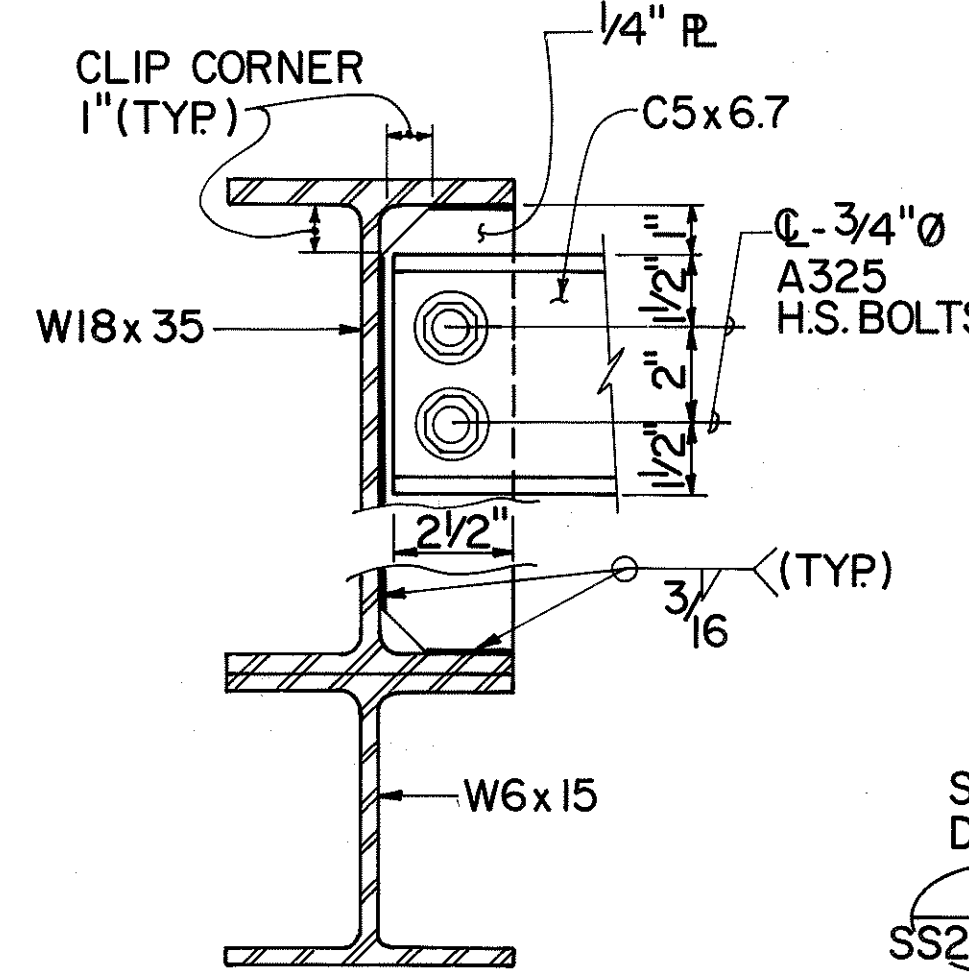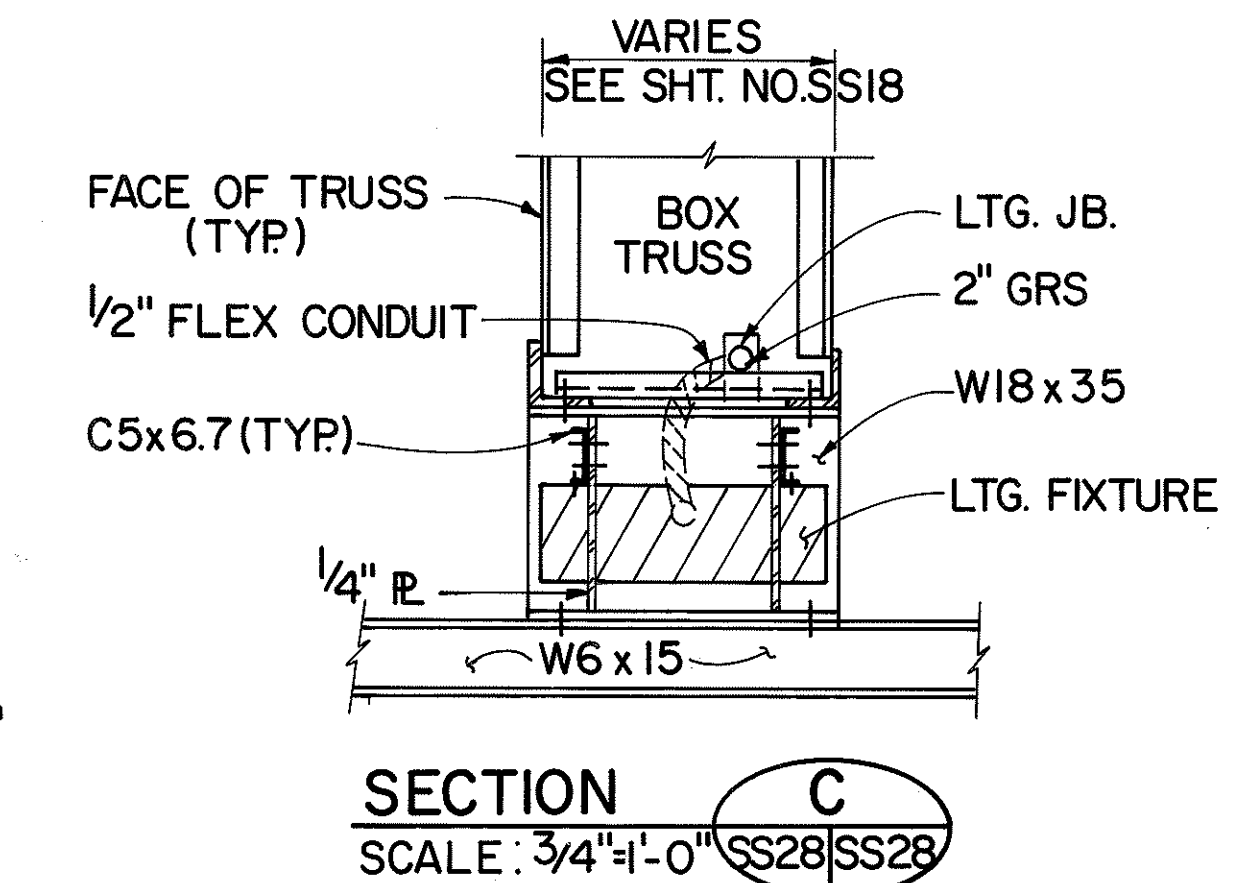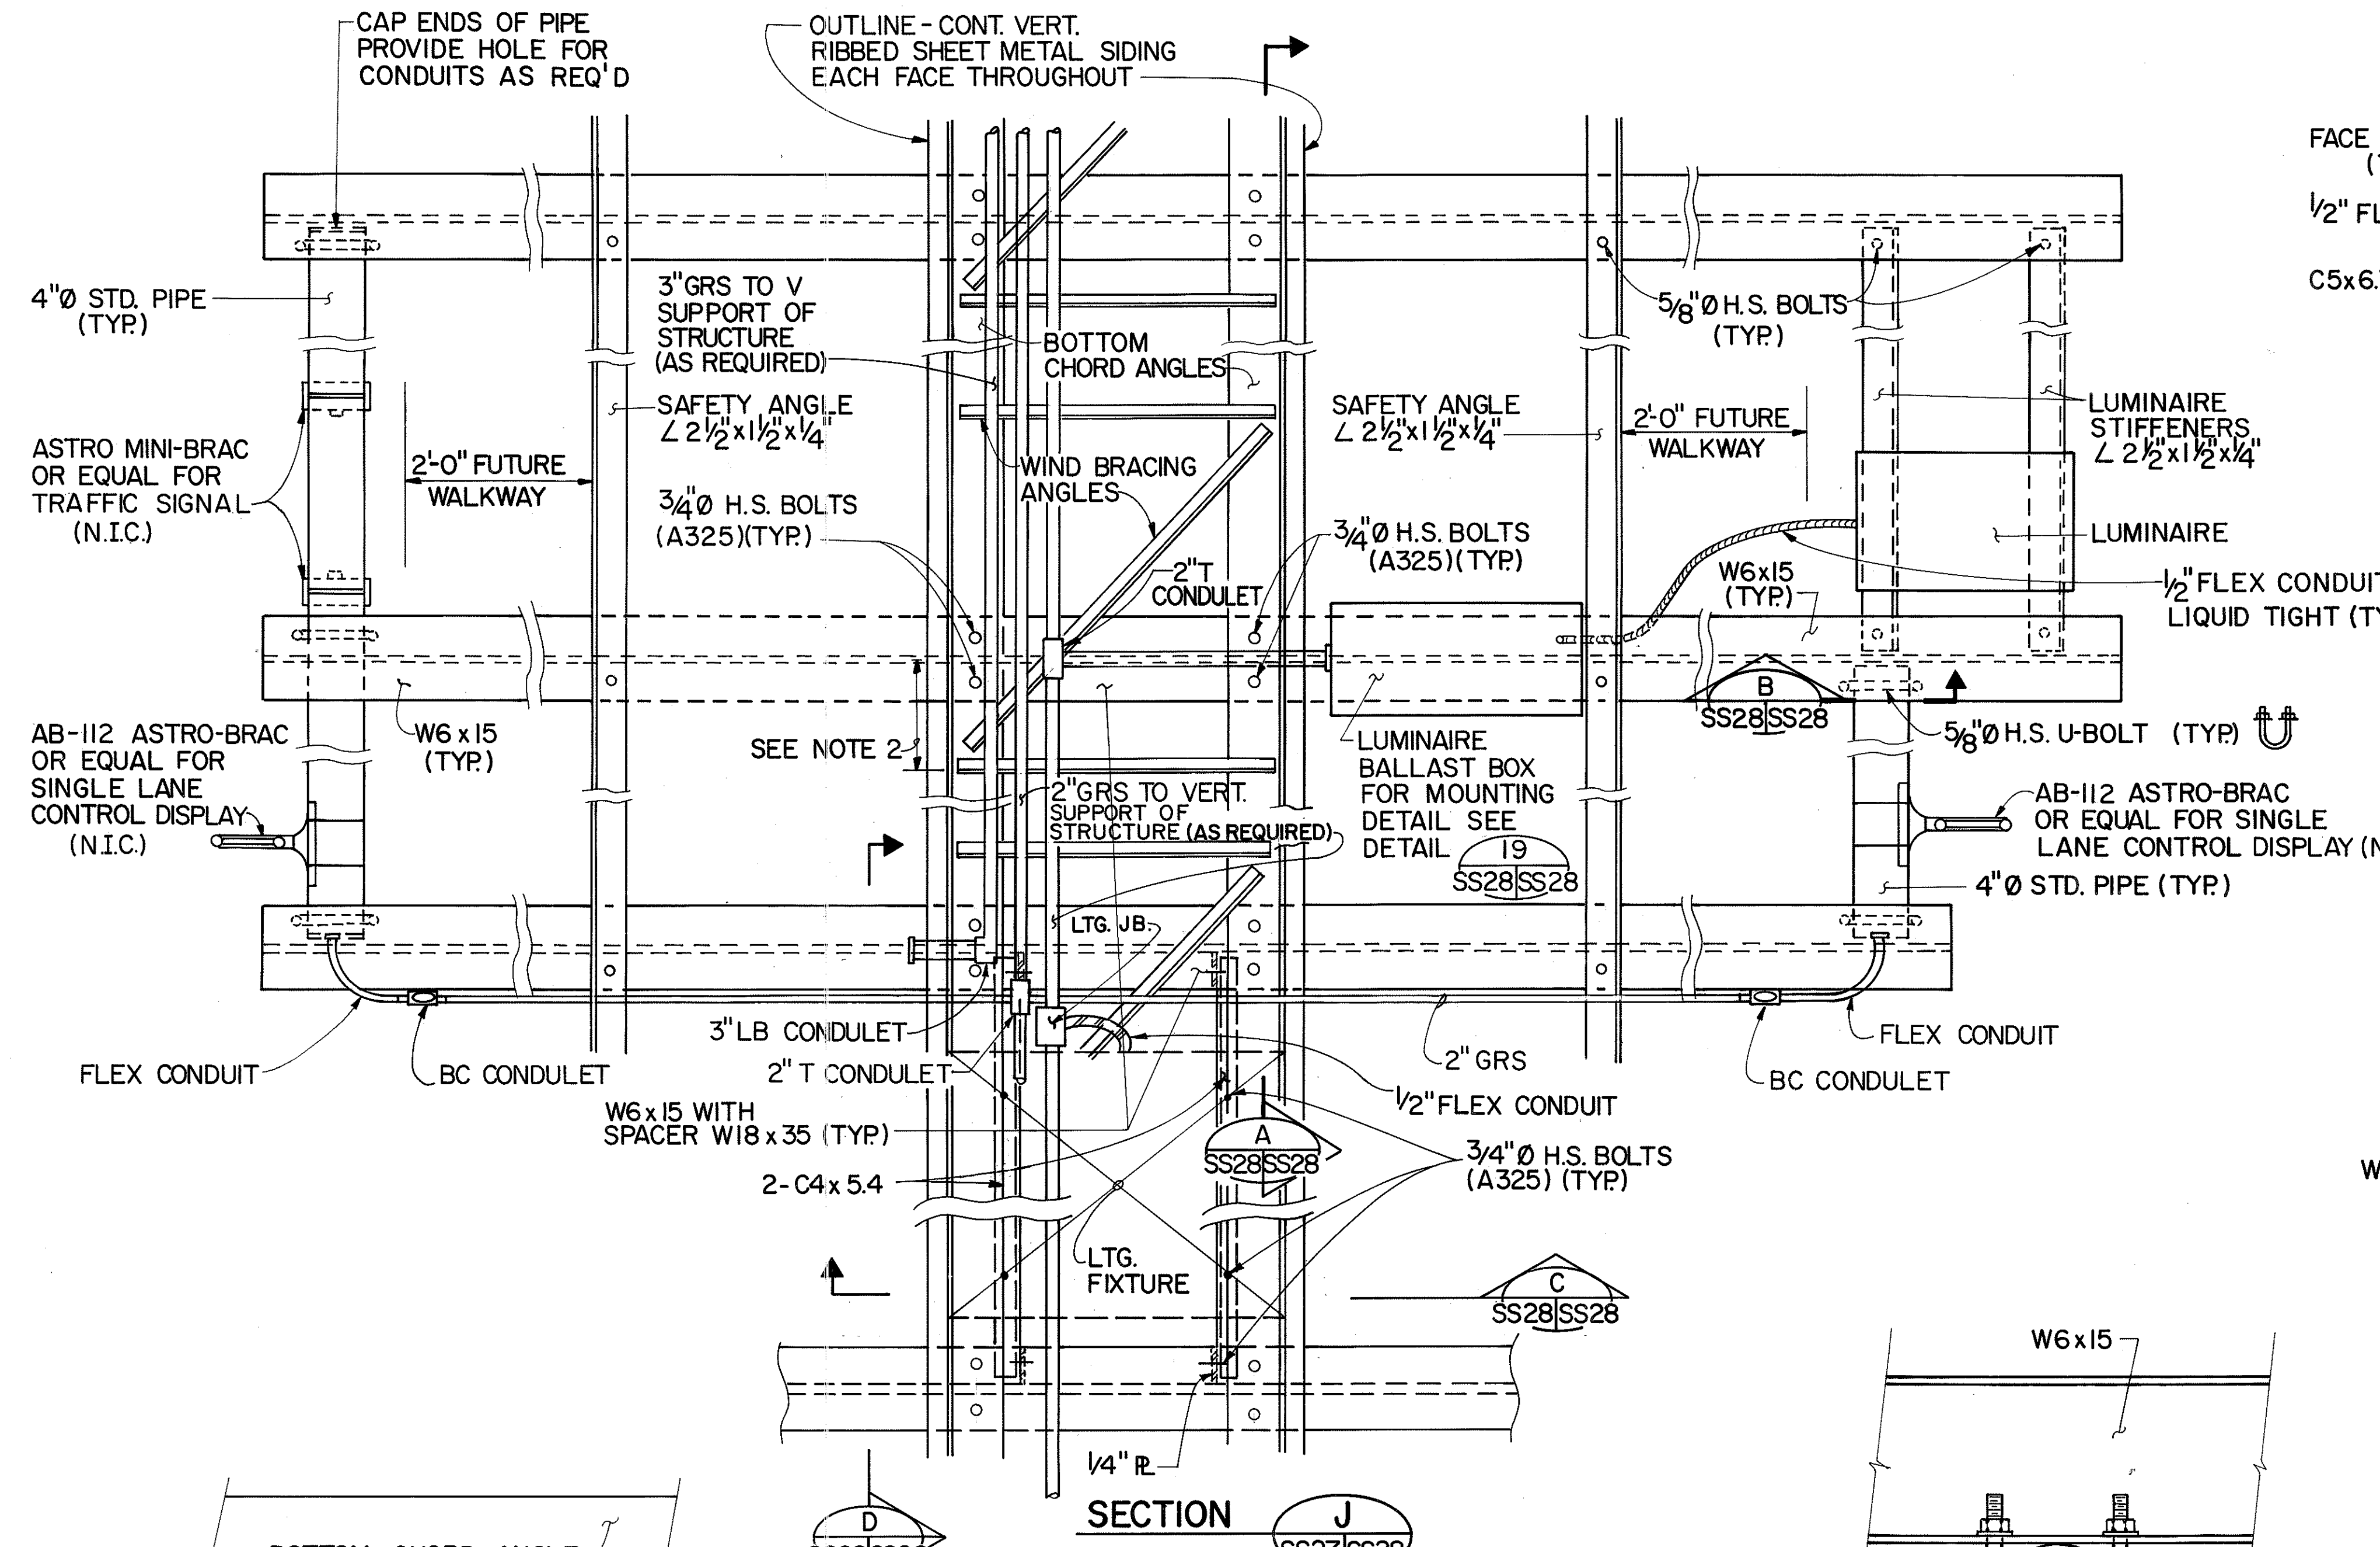

TYPICAL WALKWAY CONNECTION DETAIL
SCALE: 1 1/2" = 1'-0"

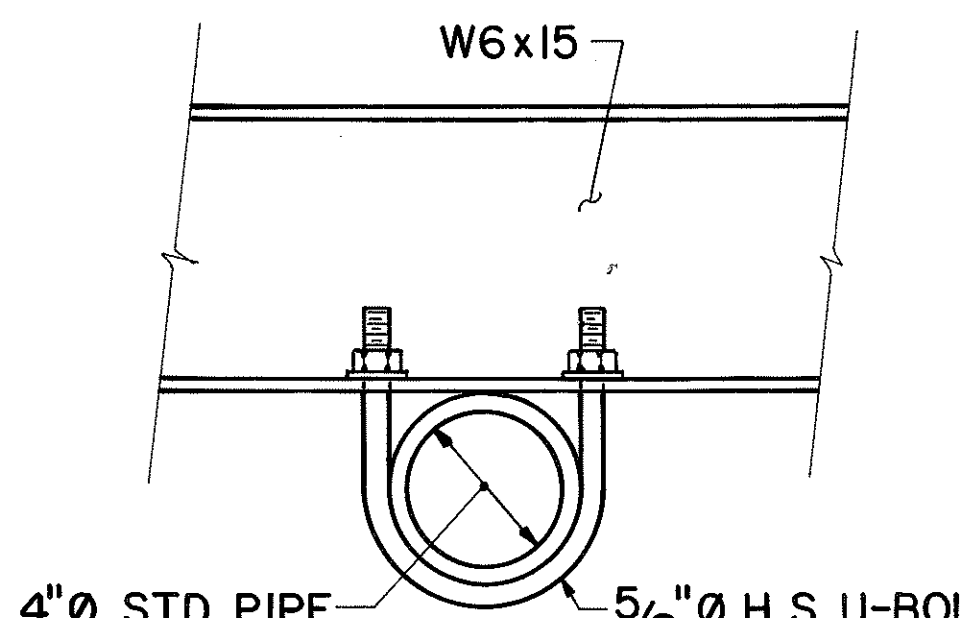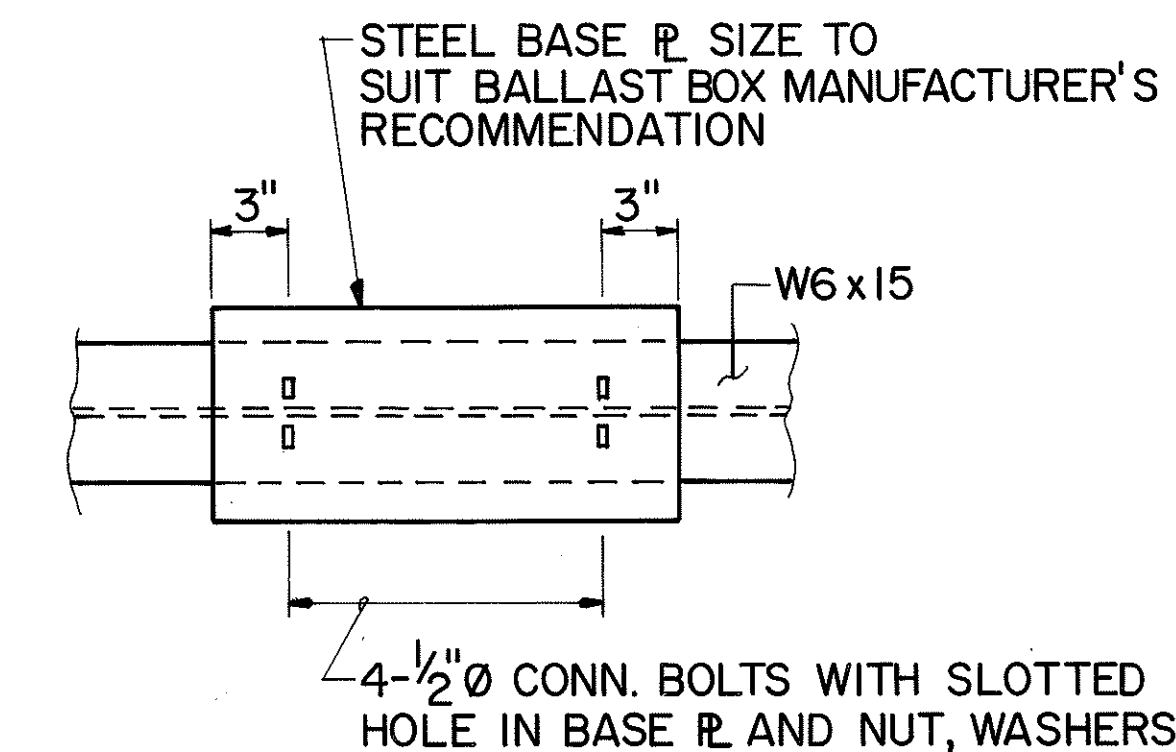


SECTION B
SCALE: 3" = 1'-0"

DETAIL 20
SCALE: 1" = 1'-0"

SECTION D
SCALE: 3/4" = 1'-0"

SECTION A
SCALE: 3" = 1'-0"

DETAIL 19
N.T.S.

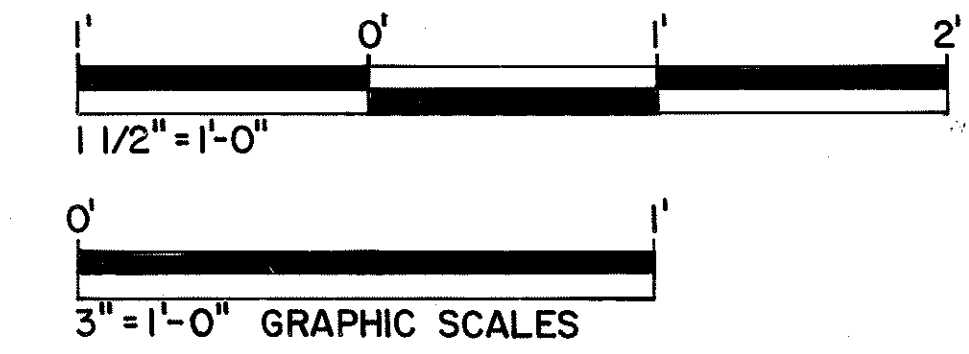

HUI FANG CHEN
REGISTERED PROFESSIONAL ENGINEER
No. 3865-S
HAWAII, U.S.A.

THIS WORK WAS PREPARED BY ME OR UNDER MY SUPERVISION.
Hui Fang Chen


7/20/93	DELETED (N.I.C.) FROM FLEX CONDUIT PER DCN 66-014
DATE	REVISION
STATE OF HAWAII DEPARTMENT OF TRANSPORTATION HIGHWAYS DIVISION WALKWAY DETAILS - 2 SUPPORT STRUCTURES INTERSTATE ROUTE H-3 F.A.I. PROJ. NO. I-H3-1(66) SCALE: AS SHOWN DATE: APR. 1992 SHEET NO. SS28 OF 36 SHEETS	

SURVEY PLOTTED BY	DATE
DRAWN BY	7/90
DESIGNED BY	7/90
CHECKED BY	3/90
NOTE BOOK	
No.	

TYPICAL BASE P

DETAIL
N. T. S.

DETAIL **IO**
SCALE: 3"=1'-0" SS16, SS17 | SS29
SS6

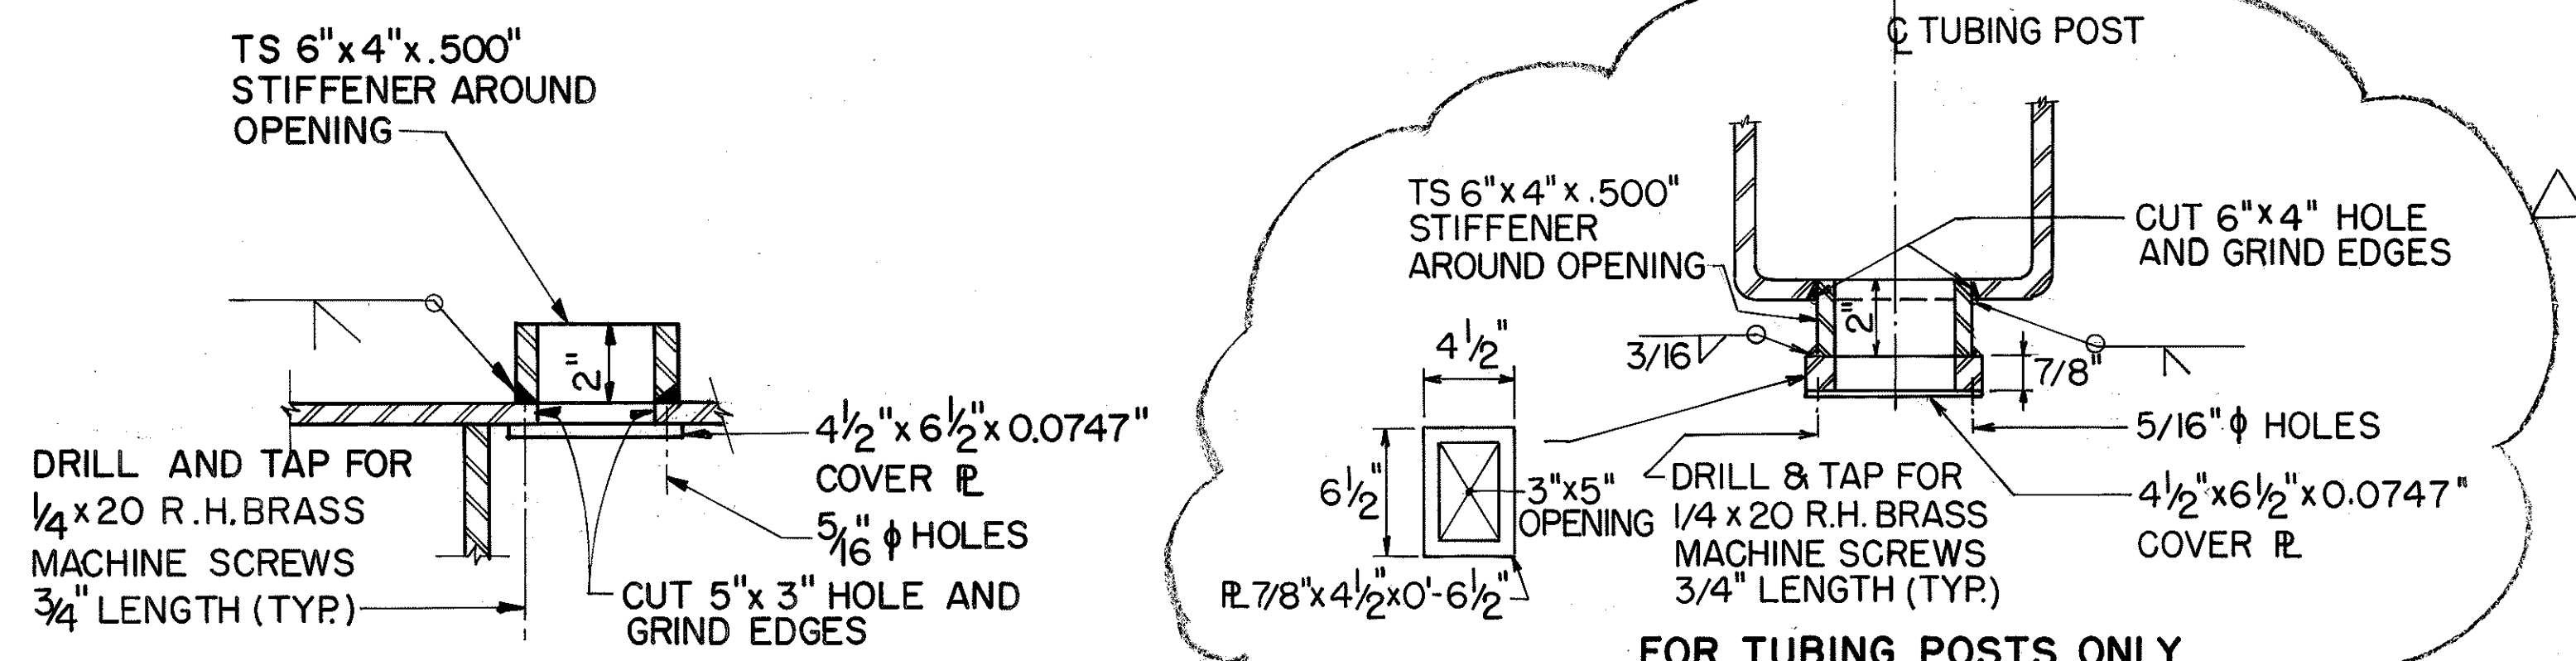

FOR TUBING POSTS ONLY

EXTERIOR ELEVATION
SCALE: 3"=1'-0"

The drawing shows a cross-section of a roof with the following details and dimensions:

- 6"**: Dimension for the first flat section.
- 3/4" MIN. 1" MAX.**: Dimension for the first vertical rise.
- 1 1/2" MIN. 2 3/8" MAX.**: Dimension for the second vertical rise.
- WEB SPLICE**: Label for the first vertical rise.
- WEB SPLICE OPTIONAL**: Label for the second vertical rise.
- 1 1/2" MIN. 1 5/8" MAX.**: Dimension for the third vertical rise.
- APPROVED BLIND RIVETS 3/16" φ @ 6" o.c. (OPTIONAL)**: Label for the rivets connecting the metal sheets.
- VERT. RIBBED SHEET METAL (GALV.) (0.0359")**: Label for the metal sheeting.

[illegible]

DETAIL 12
SCALE: 3" = 1'-0" SS16 SS29
SS30, SS31



5-25-93	REVISED SECTION C PER DCN 66-008
DATE	REVISION

STATE OF HAWAII
 DEPARTMENT OF TRANSPORTATION
 HIGHWAYS DIVISION

MISCELLANEOUS DETAILS-I

SUPPORT STRUCTURES
INTERSTATE ROUTE H-3
FA.I. PROJ. NO. I-H3-I (66)



SCALE: AS SHOWN DATE: APR. 1992

SHEET No. SS29OF 36 SHEETS



0' 1'
 3" = 1'-0" GRAPHIC SCALE

FED. ROAD DIST. NO.	STATE	FED. AID PROJ. NO.	FISCAL YEAR	SHEET NO.	TOTAL SHEETS
HAWAII	HAW.	I-H3-1(66)	1992	392	440


NOTE:
THE CONTRACTOR SHALL PROVIDE SPLICE OF TUBING STRUT AT THE LOCATIONS AS SHOWN ON PLANS. IN CASE ADDITIONAL SPLICES OF TUBING STRUT ARE REQUIRED, THE SPLICES SHALL BE LOCATED AT ABOUT 1/4 SPAN FROM ϕ OF SUPPORT AND INTERFERENCE WITH THE FARADAY SHIELD WIRE CONNECTIONS SHALL BE AVOIDED. IN NO CASE SHALL SPLICES BE LOCATED AT MIDSPAN OF THE STRUT. LOCATIONS OF SPLICES SHALL BE INDICATED ON SHOP FABRICATION DRAWINGS FOR APPROVAL. FOR STRUTS THROUGH WHICH WIRES WILL BE PULLED, PLACE HANDHOLE ON BOTTOM-SIDE OF STRUT WHERE ADDITIONAL SPLICES ARE PROVIDED. NEAREST EDGE OF HANDHOLE COVER ϕ IS 1'-0" FROM ϕ SPLICE & CENTERED ABOUT ϕ STRUT. HANDHOLE NEEDED ONLY ON SIDE OF SPLICE NEAREST SUPPORT POSTS PROVIDING CONDUIT STUBOUTS FOR WIRE ACCESS. SEE DETAIL 12 FOR HANDHOLE DETAILS.

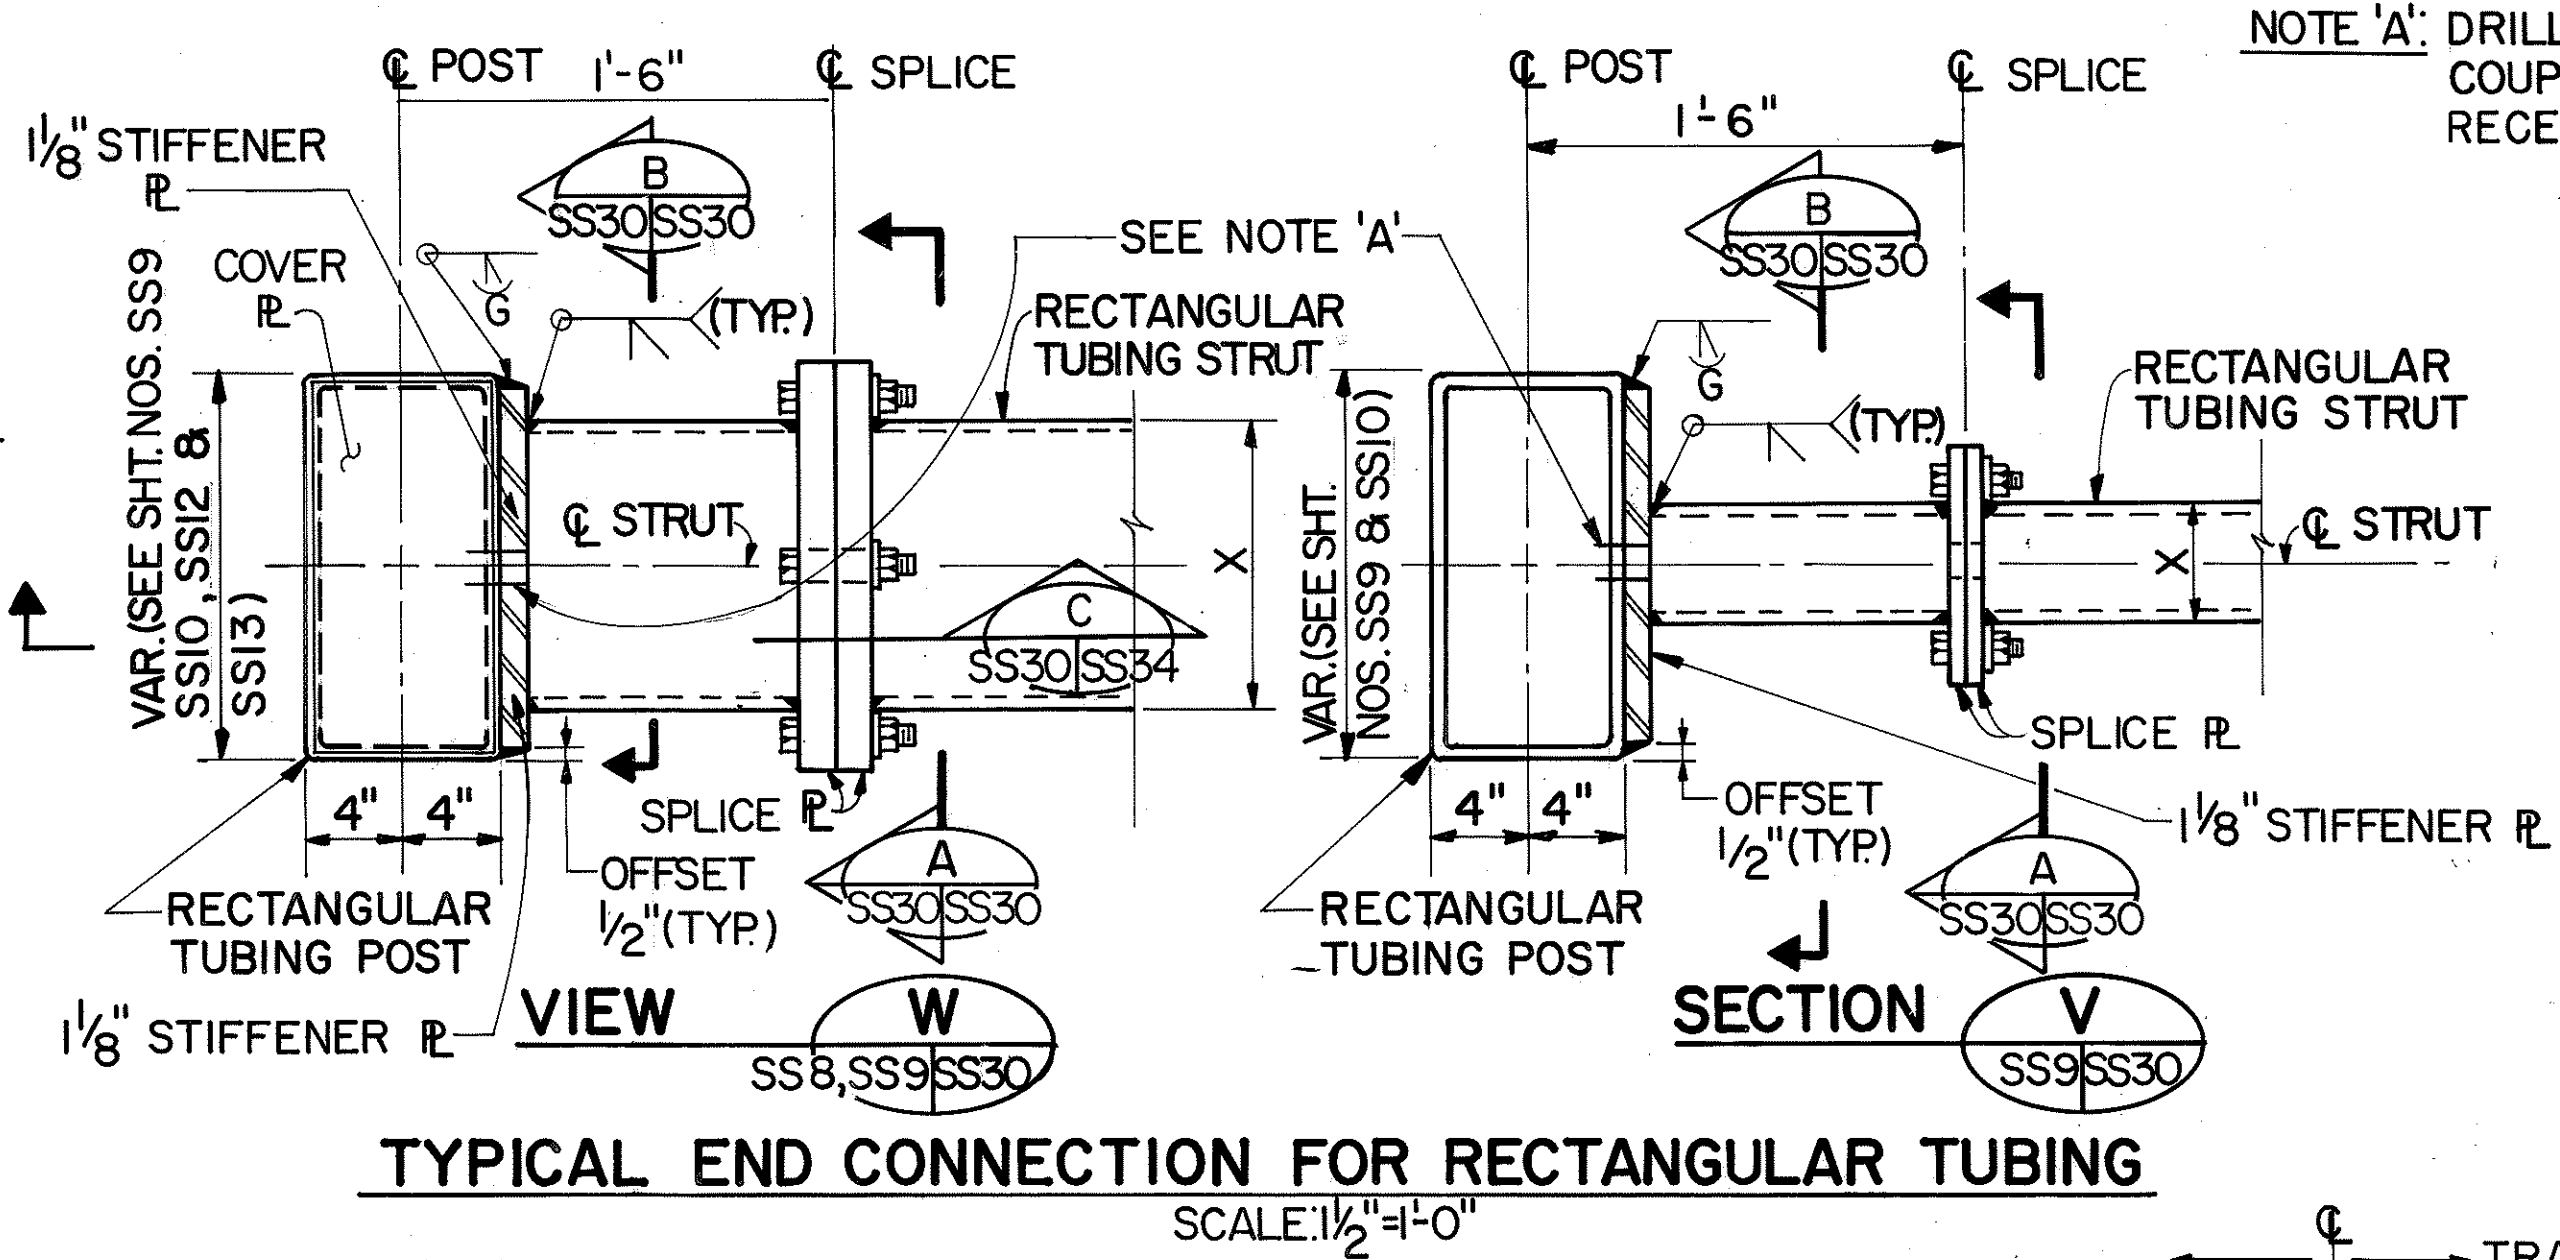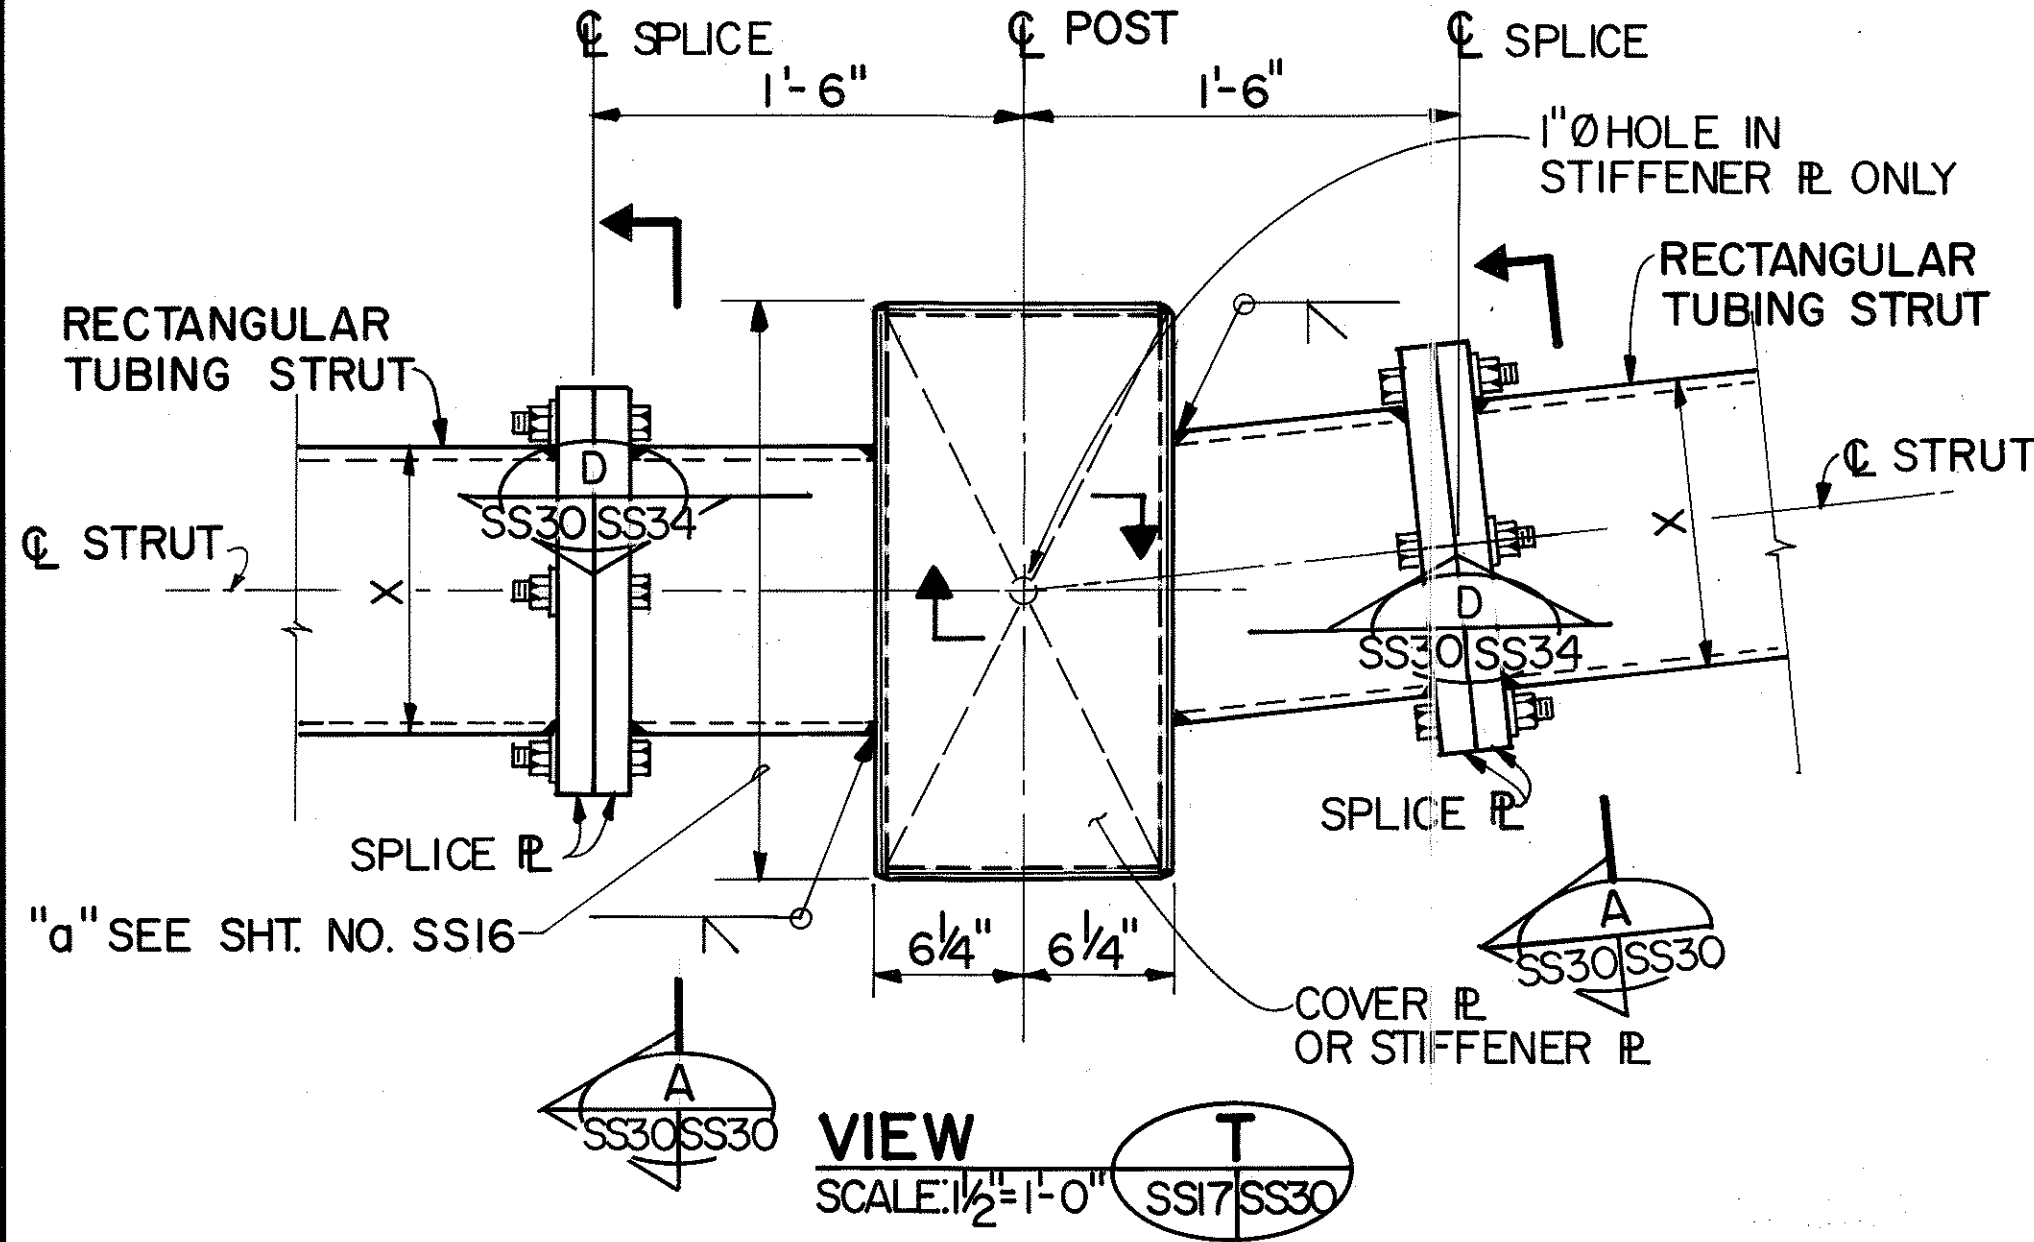

TYPICAL END CONNECTION FOR RECTANGULAR TUBING

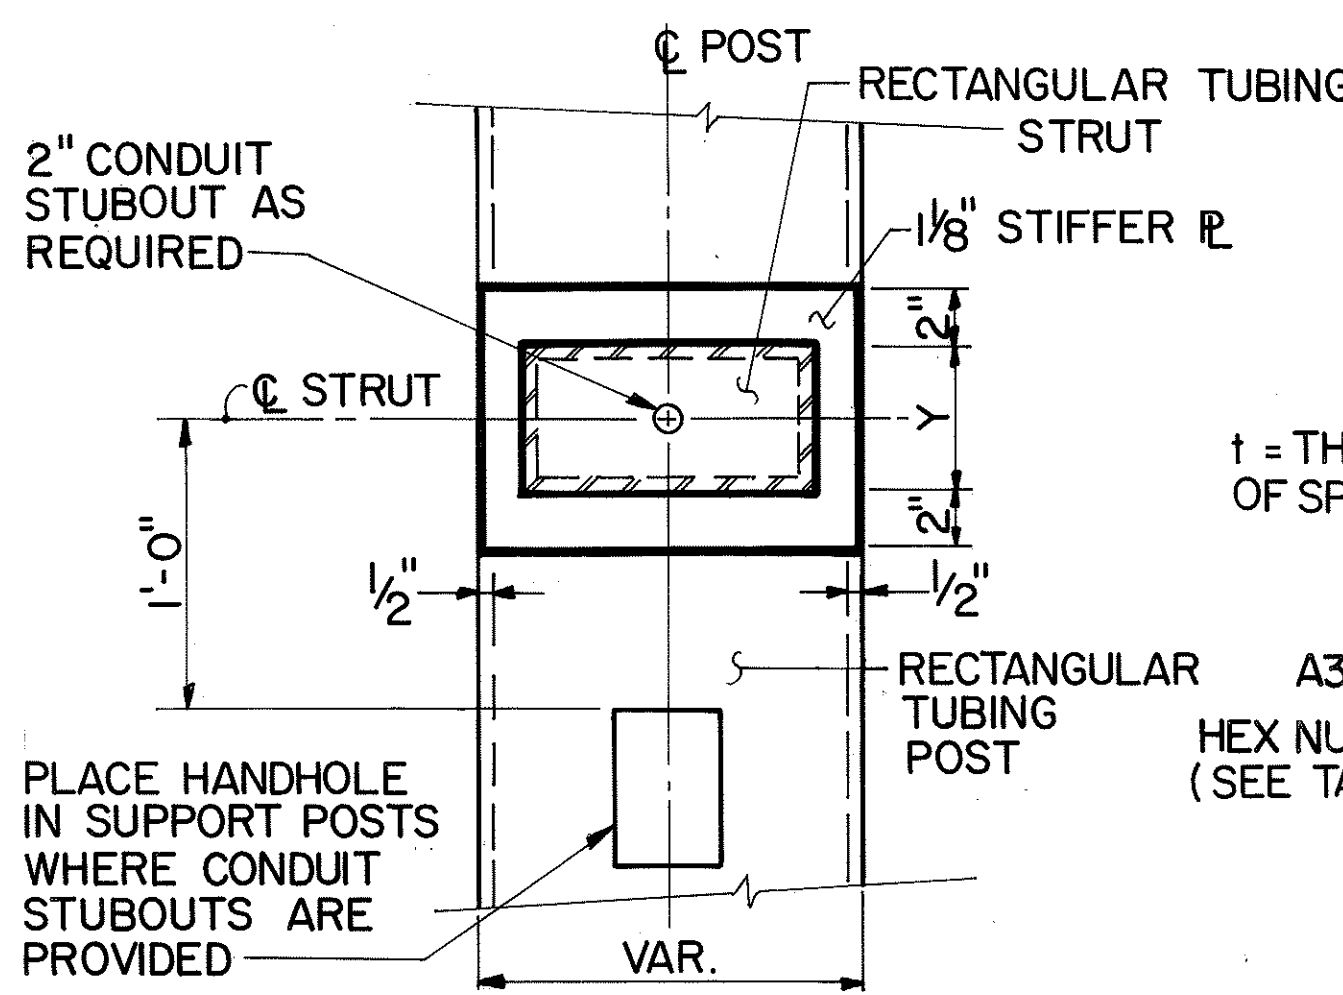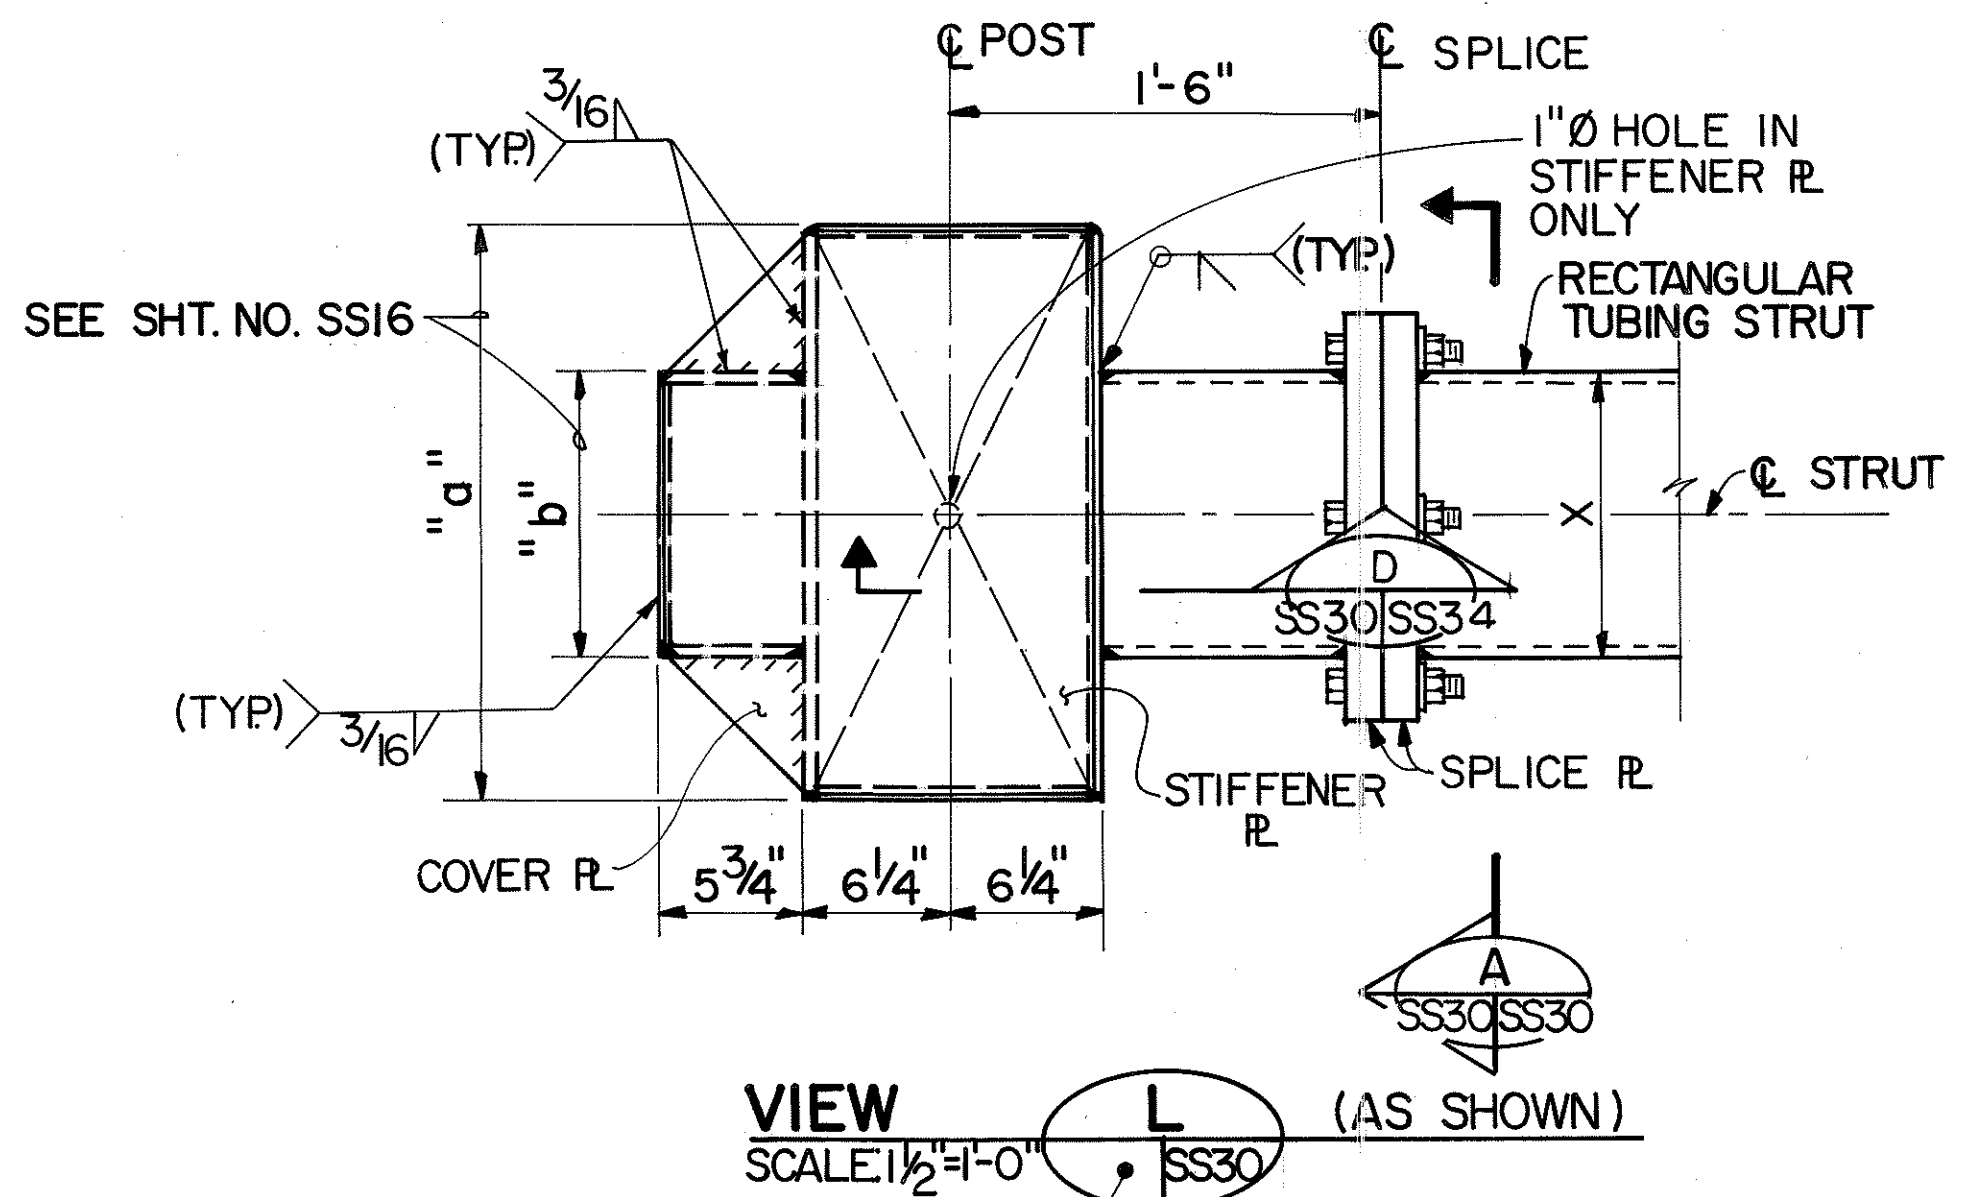


SECTION B


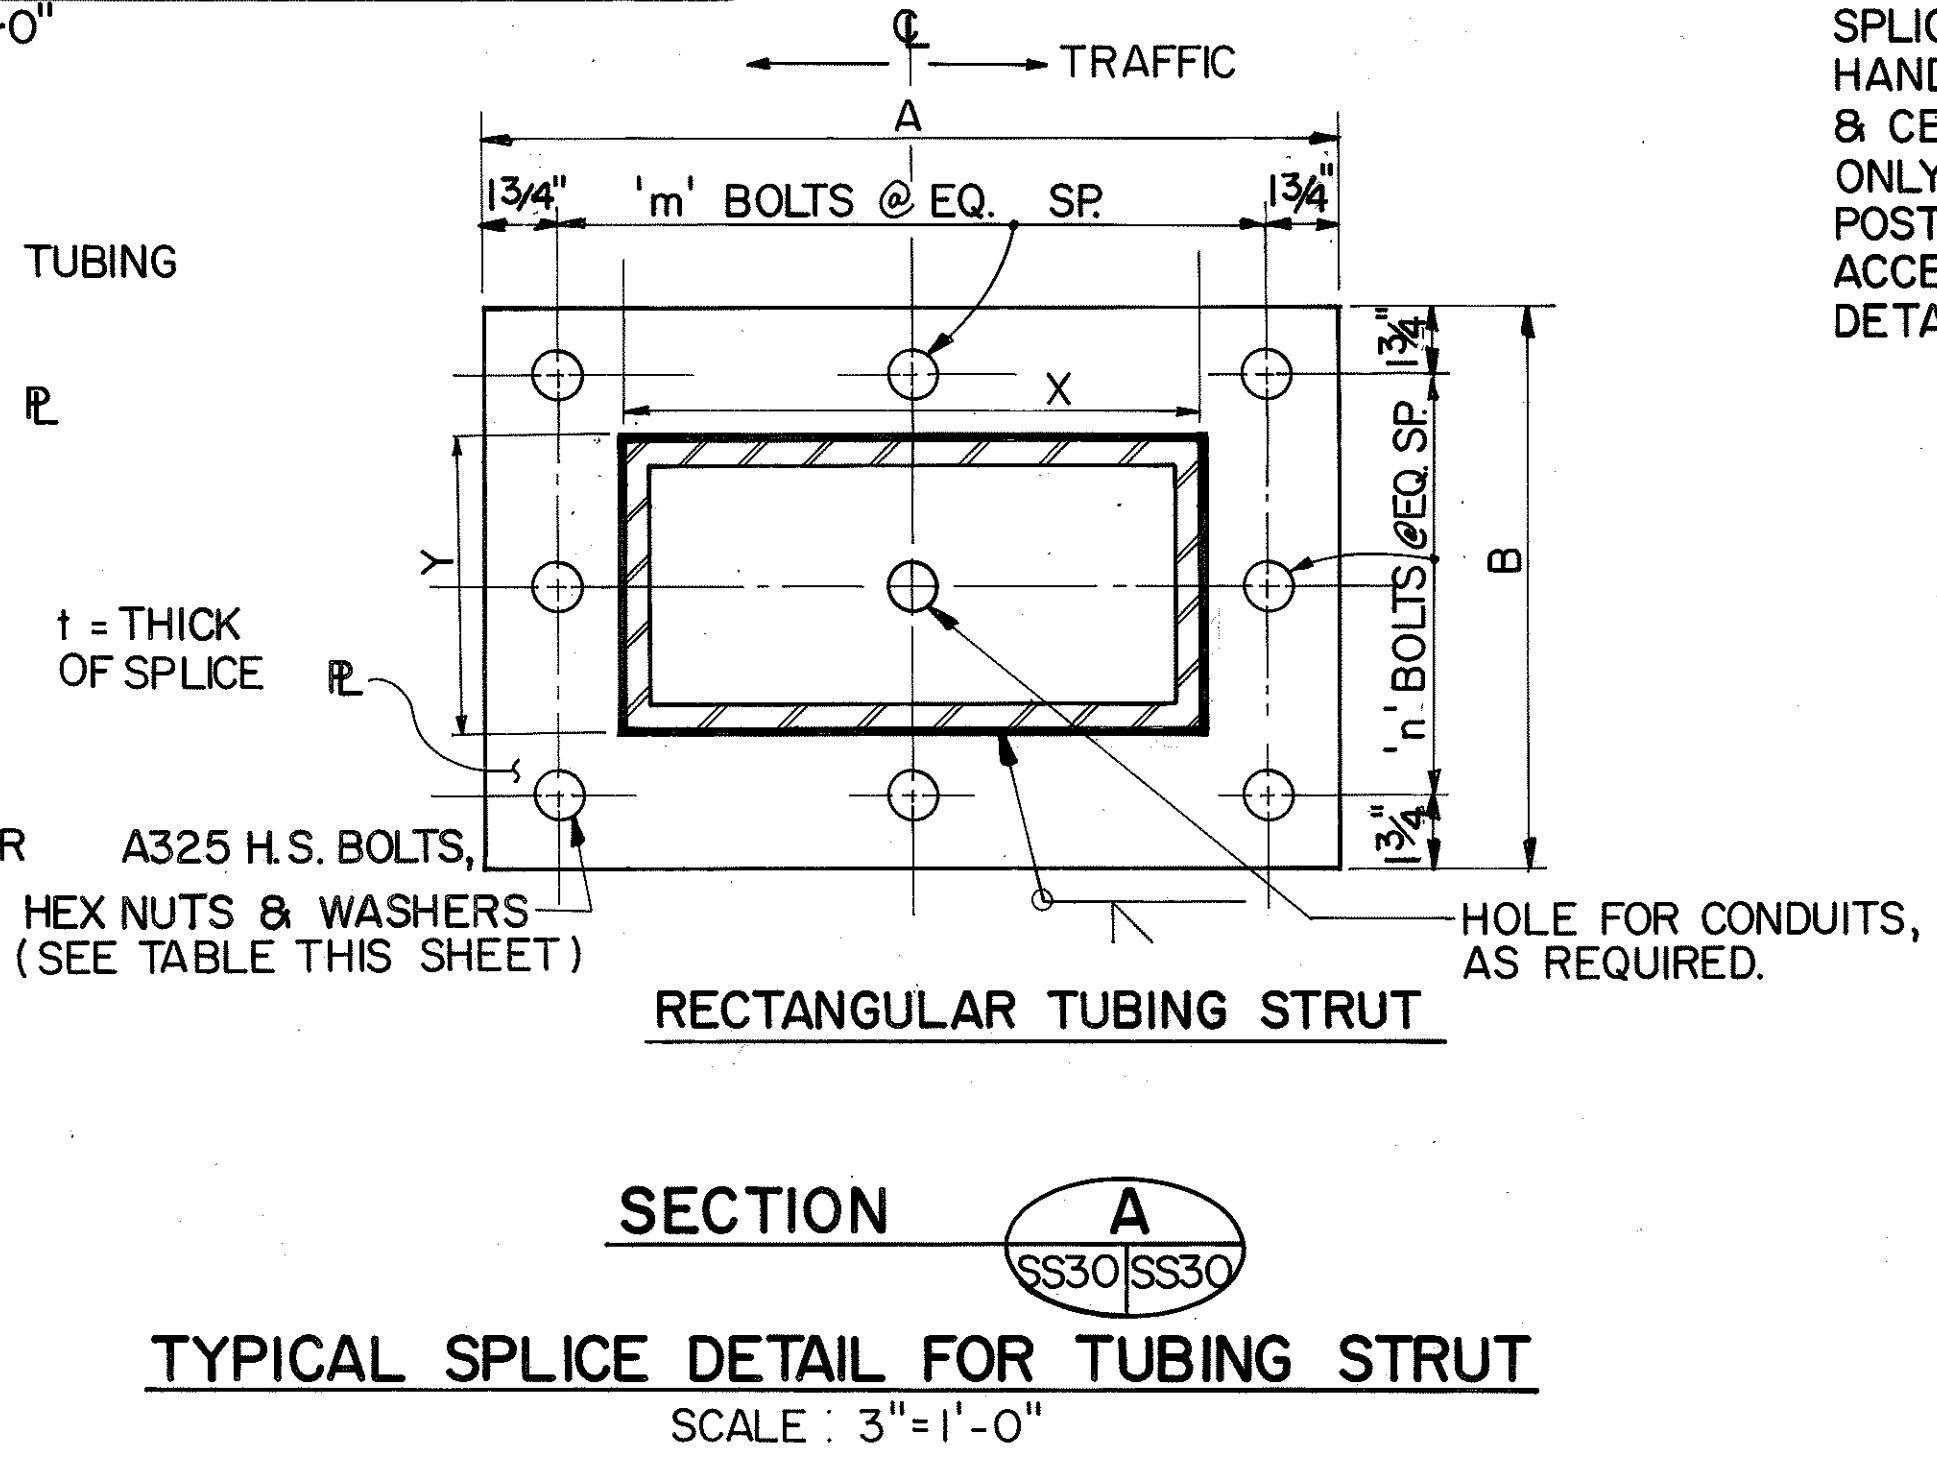


TYPICAL SPLICE DETAIL FOR TUBING STRUT

RECTANGULAR TUBING STRUT	X	Y	A	B	NO. OF BOLTS		t	BOLT HOLE SIZE	BOLT SIZE
					m	n			
8" x 6" x 1/2"	8	6	1'-6 1/2"	1'-3 1/2"	4	3	1 5/8"	15/16"	3/4"
12" x 6" x 1/2"	12	6	1'-9 1/2"	1'-3 1/2"	4	3	1 3/4"	1 1/4"	1"
18" x 6" x 1/2"	18	6	2'-3 1/2"	1'-3 1/2"	5	3	2"	1 1/4"	1"
16" x 12" x 1/2"	12	16	1'-7 1/2"	2'-1 1/2"	4	5	2"	1 1/4"	1"

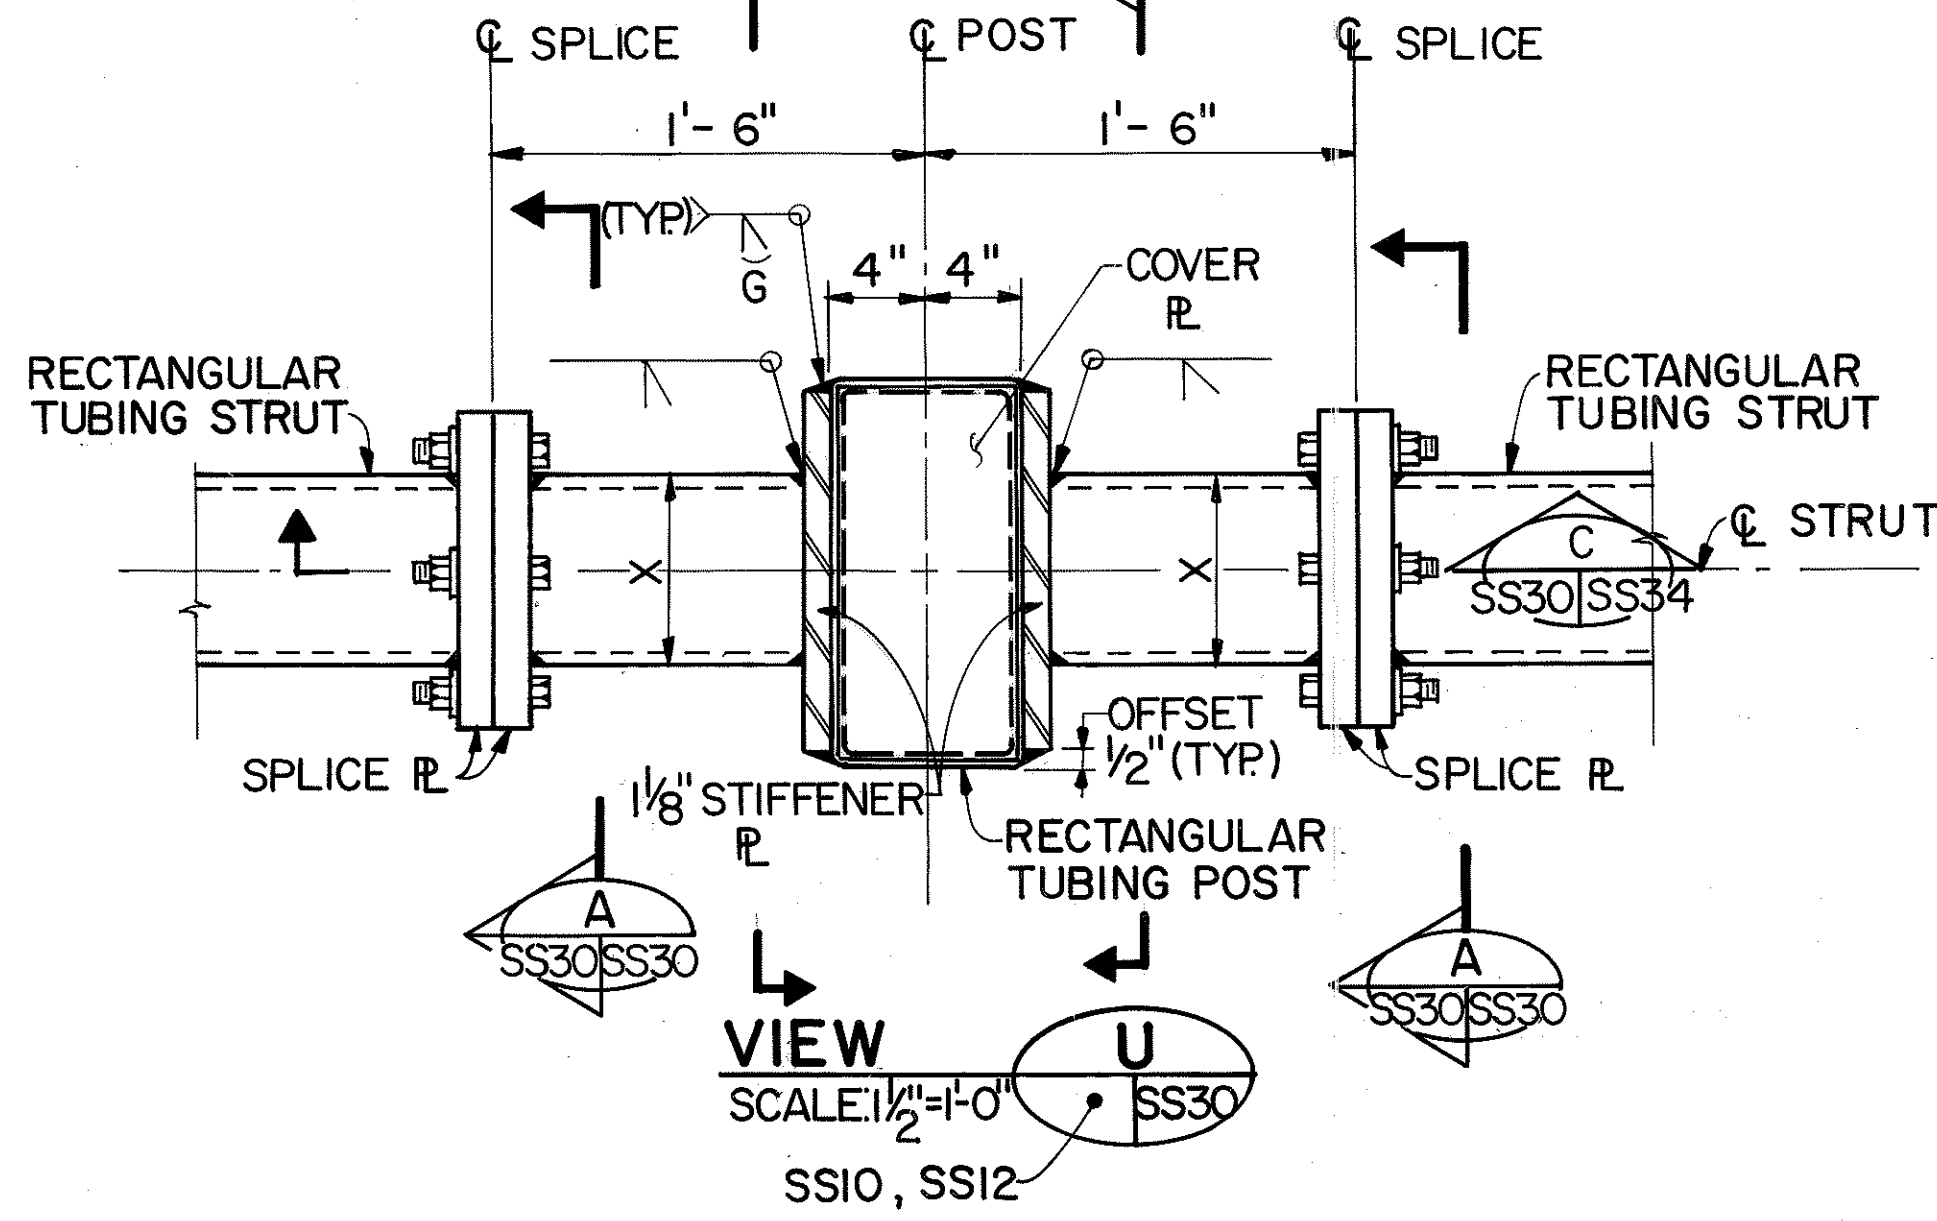

ORIGINAL PLAN	DATE	1/90
SURVEY PLOTTED BY	DATE	1/90
DRAWN BY	DATE	1/90
DESIGNED BY	DATE	1/90
CHECKED BY	DATE	1/90

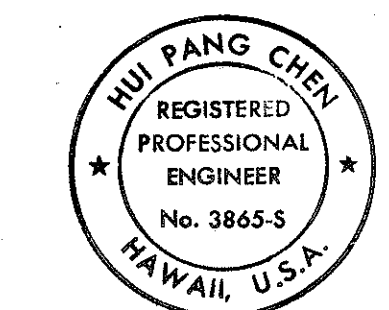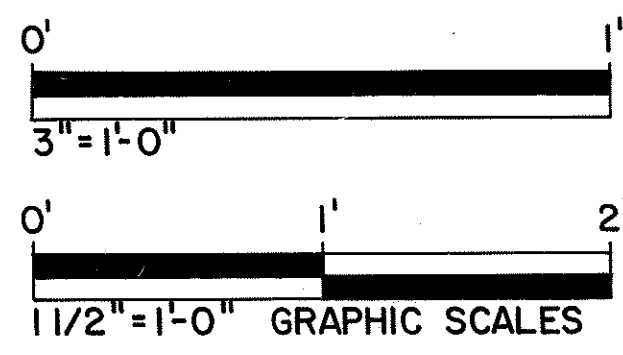


THIS WORK WAS PREPARED BY ME OR UNDER MY SUPERVISION.
Hui Pang Chen

12/29/93 REV. DIM. A & B IN TABLE PER DCN 66-027
7/20/93 REVISED SECTION 'A' AND TABLE PER DCN 66-015
5-25-93 REVISED NOTE 'A' PER DCN 66-008


DATE	REVISION

STATE OF HAWAII
DEPARTMENT OF TRANSPORTATION
HIGHWAYS DIVISION
MISCELLANEOUS DETAILS-2
SUPPORT STRUCTURES
INTERSTATE ROUTE H-3
F.A.I. PROJ. NO. I-H3-1(66)
SCALE: AS SHOWN DATE: APR. 1992
SHEET No. SS30OF 36 SHEETS


FED. ROAD DIST. NO.	STATE	FED. AID PROJ. NO.	FISCAL YEAR	SHEET NO.	TOTAL SHEETS
HAWAII	HAW.	I-H3-1(66)	1992	393	440

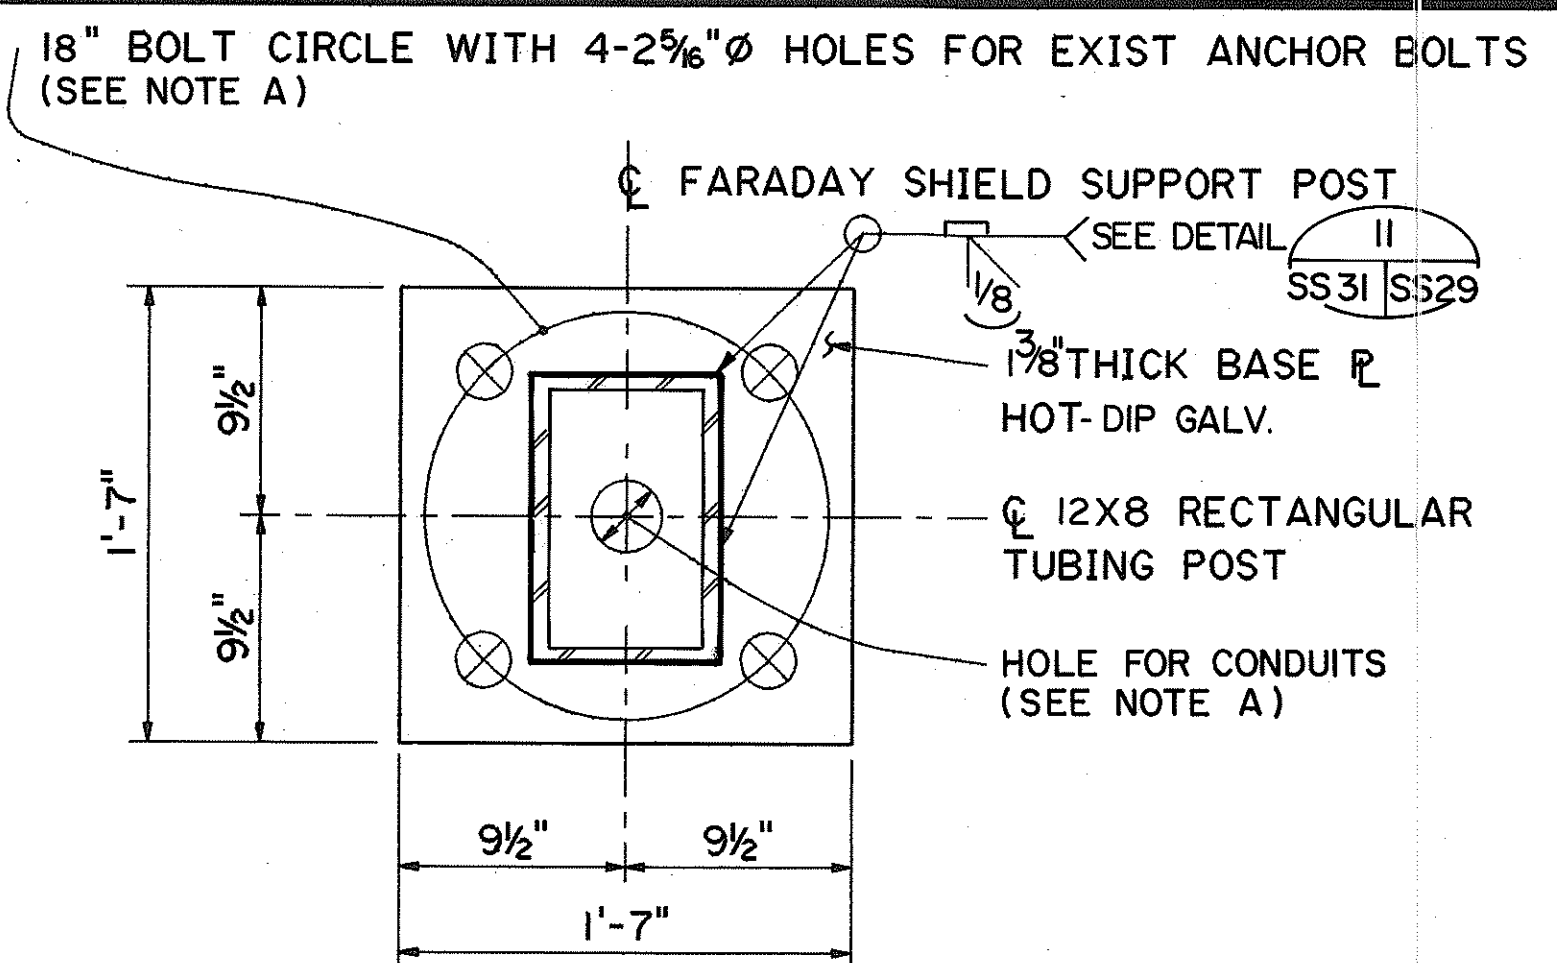

12x8 RECTANGULAR TUBING POST

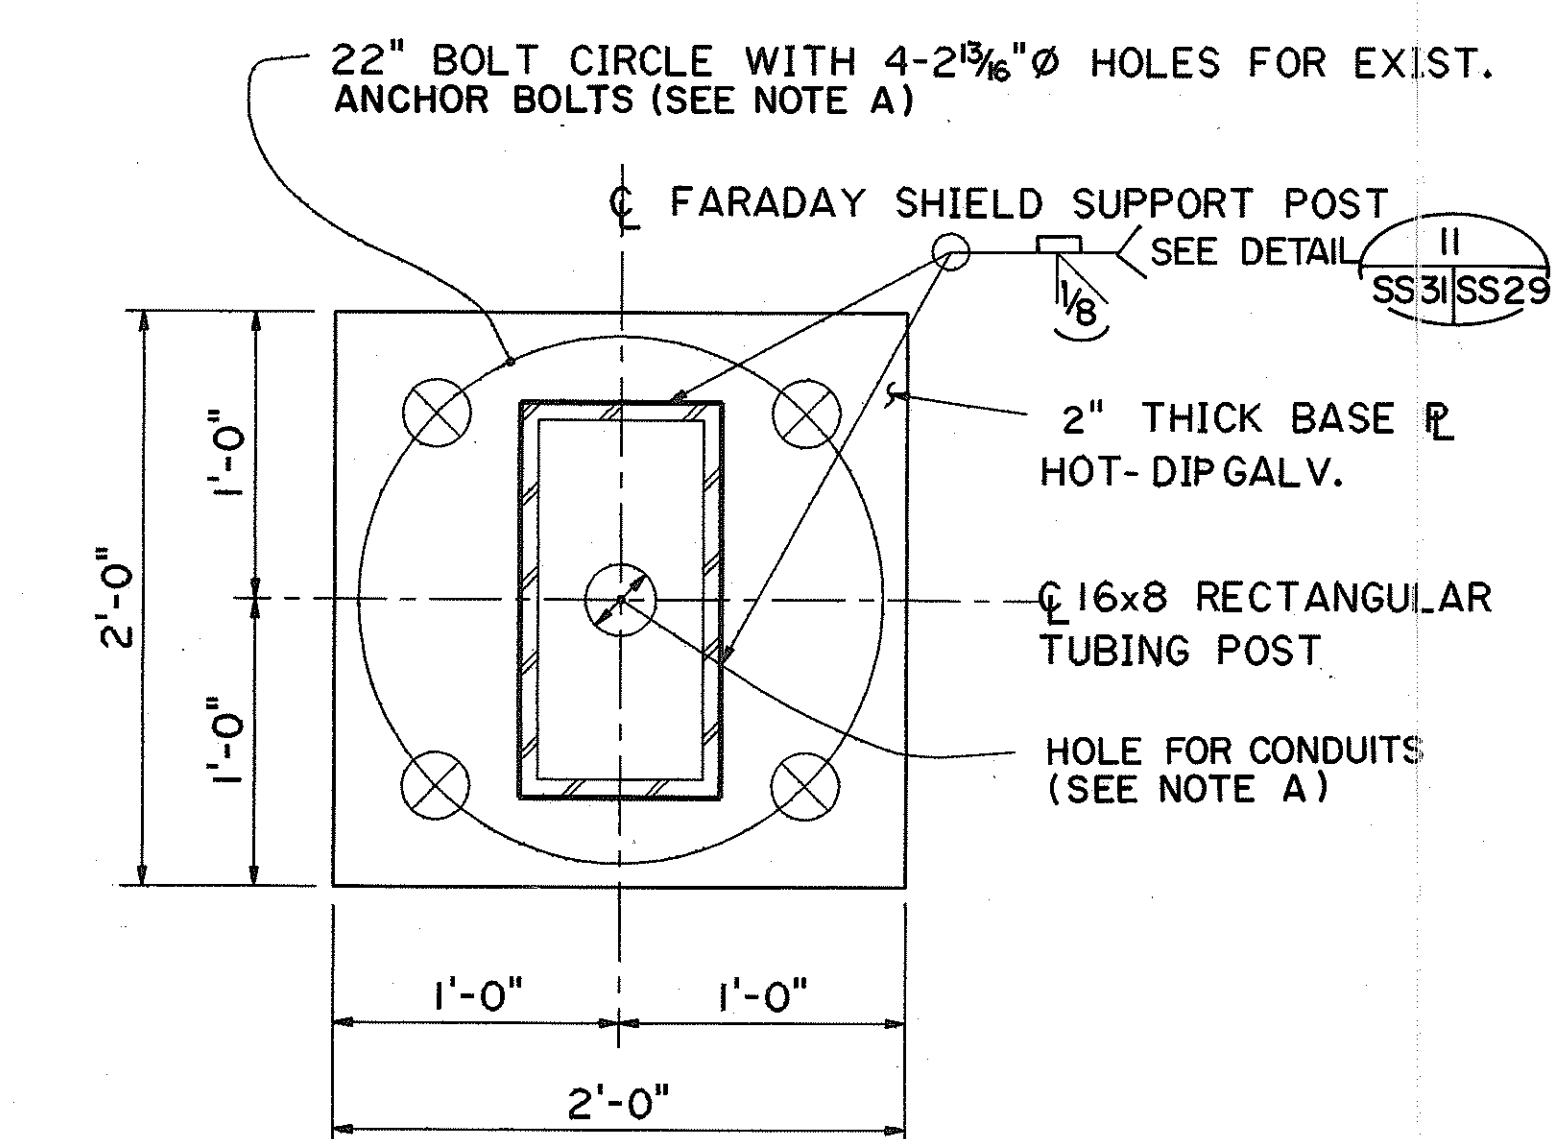


16x8 RECTANGULAR TUBING POST

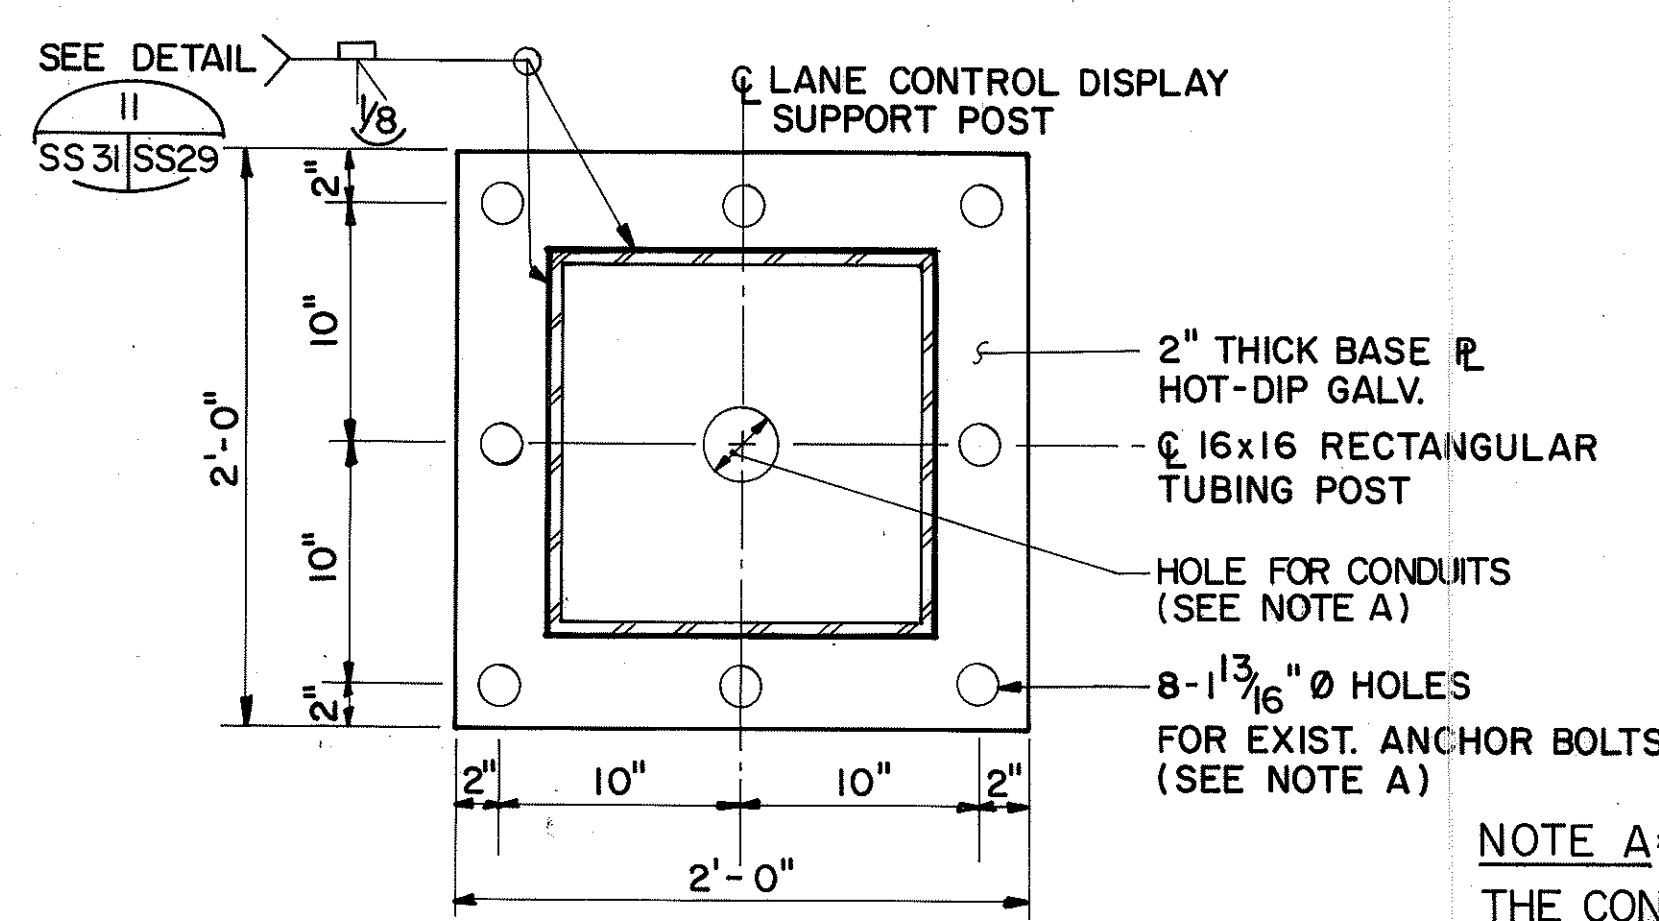

16x16 RECTANGULAR TUBING POST


SECTION I
SS8, SS9, SS10, SS12, SS31

TYPICAL BASE PLATE FOR GROUND-MOUNTED POST
SCALE: 1 1/2" = 1'-0"

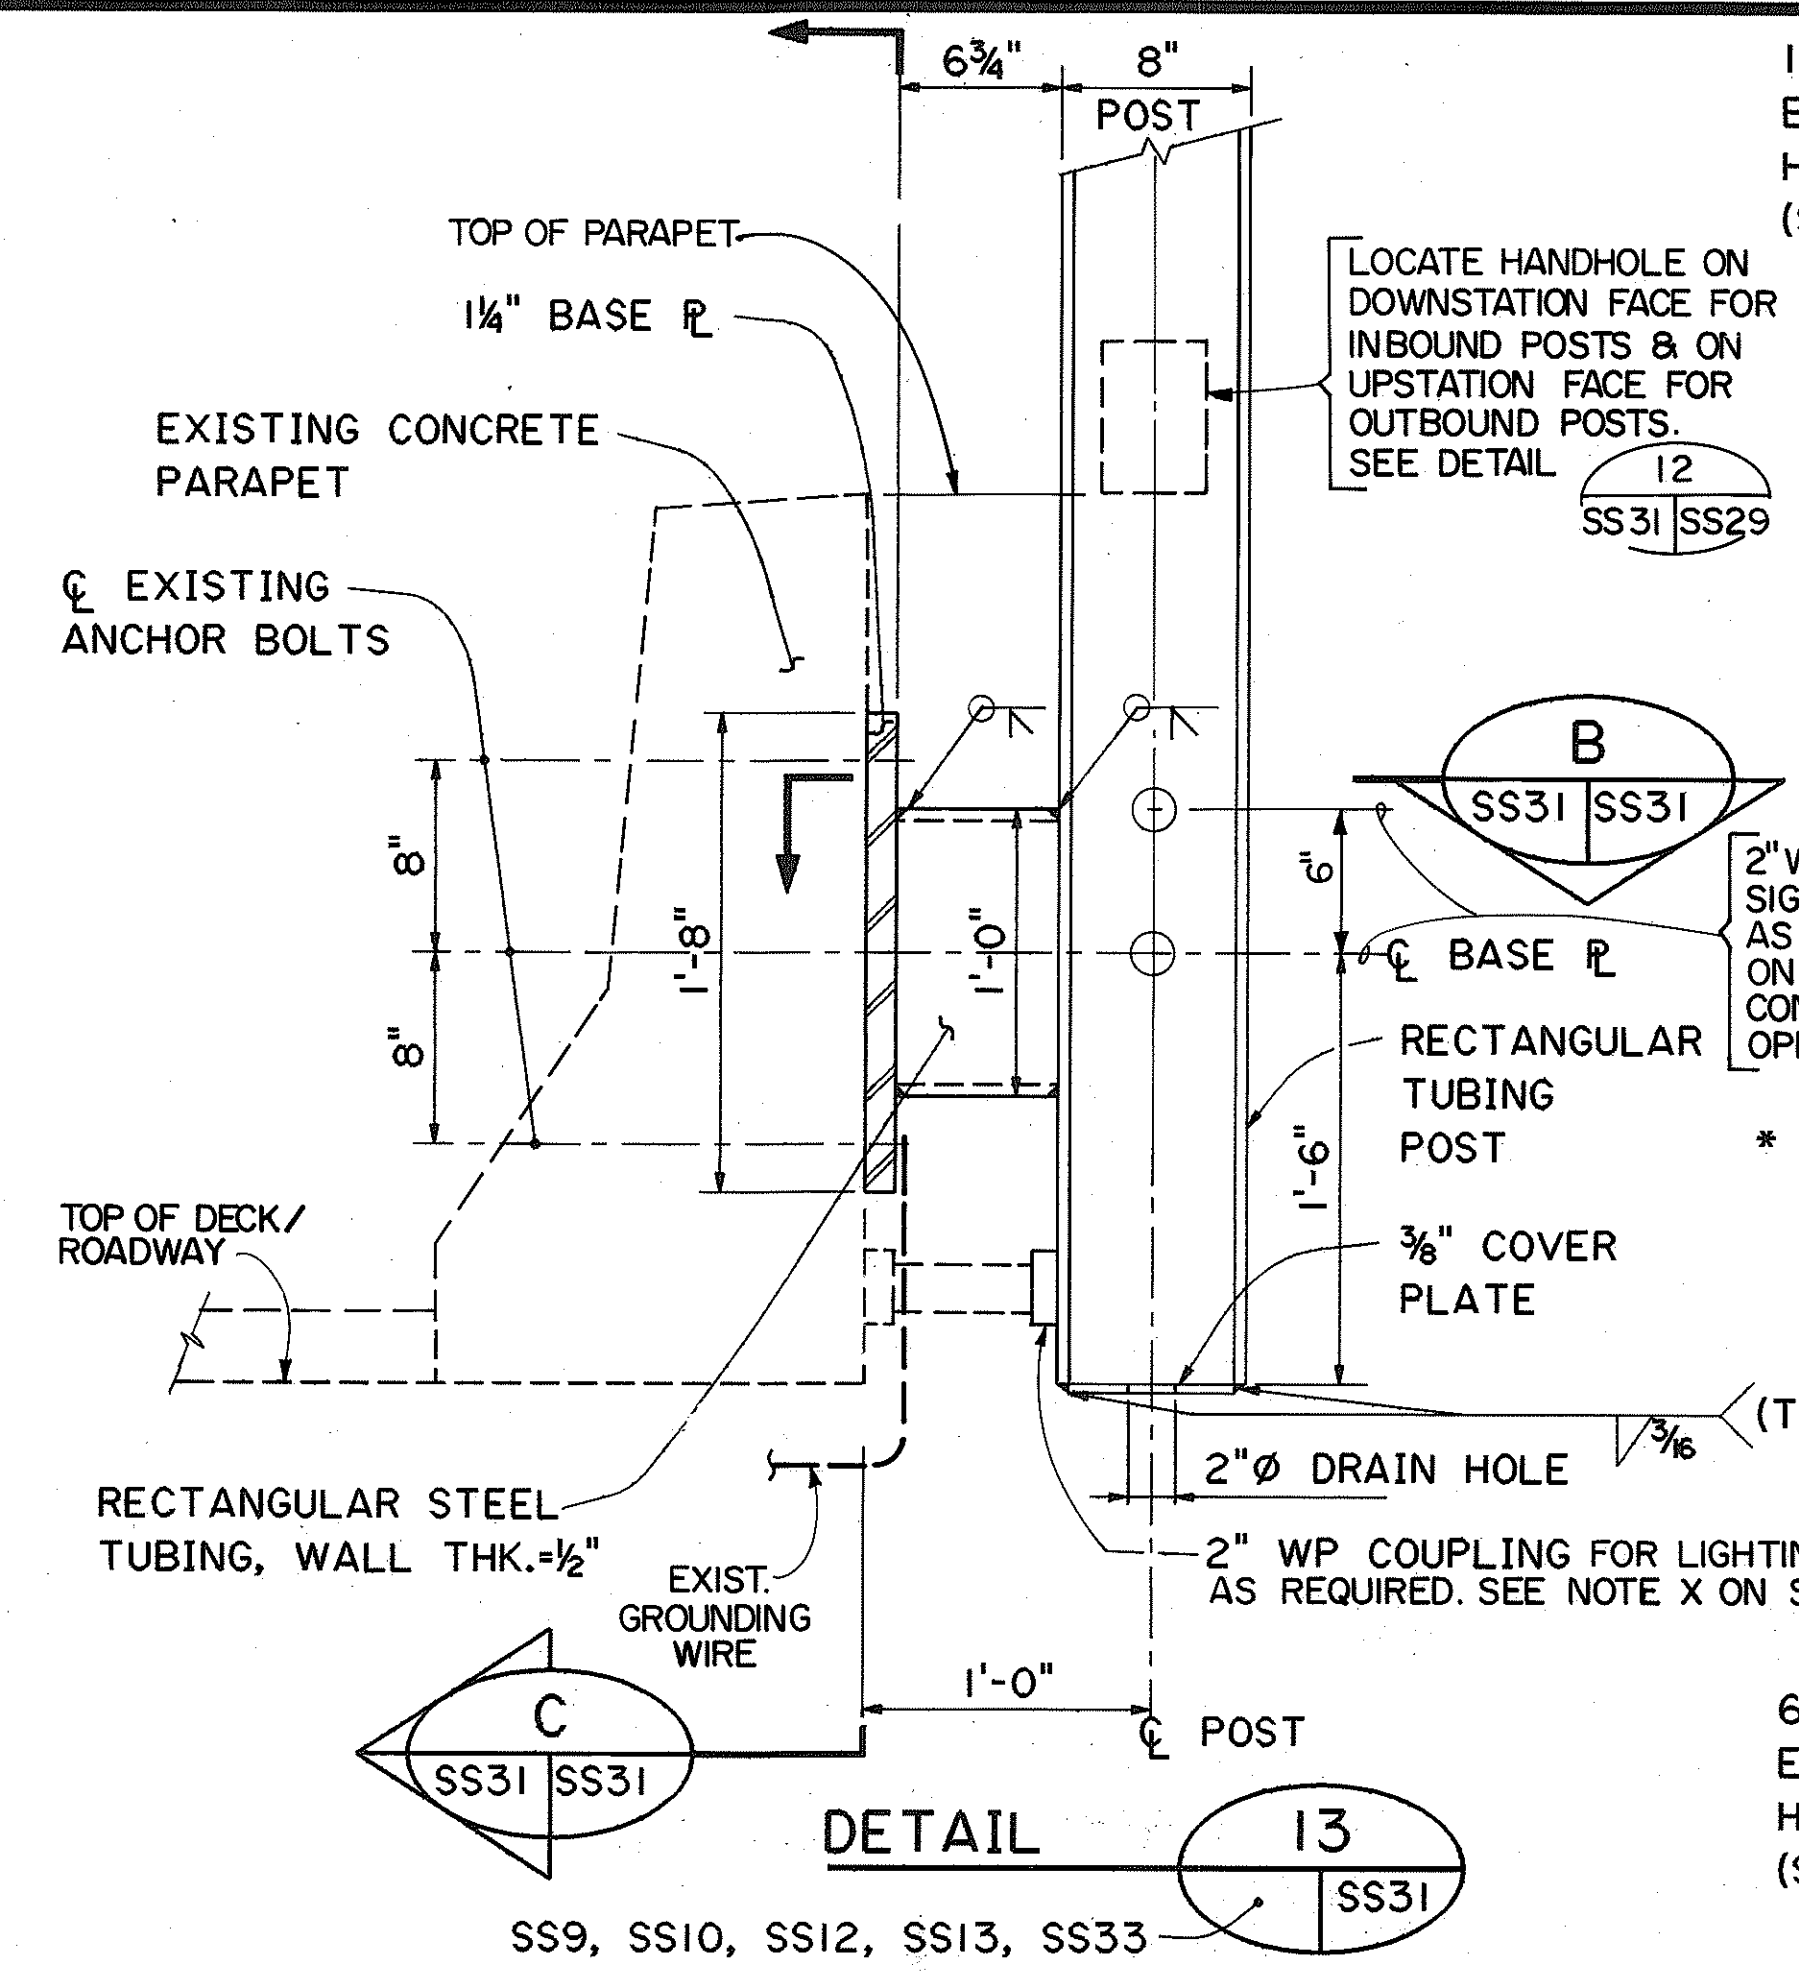


TYPICAL BASE CONNECTION DETAIL FOR PARAPET MOUNTED TUBING POST
SCALE: 1 1/2" = 1'-0"



NOTE A:
THE CONTRACTOR SHALL VERIFY THE LOCATIONS OF THE EXIST. ANCHOR BOLTS & THE NUMBER AND SIZES OF CONDUITS IN THE FIELD PRIOR TO FABRICATION OF BASE PLATE.
PROVIDE STANDARD-SIZE HOLES (1-5/16" Ø) IN BASE PLATE FOR EXIST. ANCHOR BOLTS AT TYPE II BASE CONNECTION FOR FARADAY SHIELD SUPPORT STRUCTURES ADJACENT TO EXPANSION JOINTS.
IB STA. 274+77.04, 285+05.53, 285+97.07 & 296+53.70
OB STA. 274+61.54, 285+74.49, 286+63.49 & 298+62.28
PROVIDE HOLES DIMENSIONED AS SHOWN AT ALL OTHER LOCATIONS.

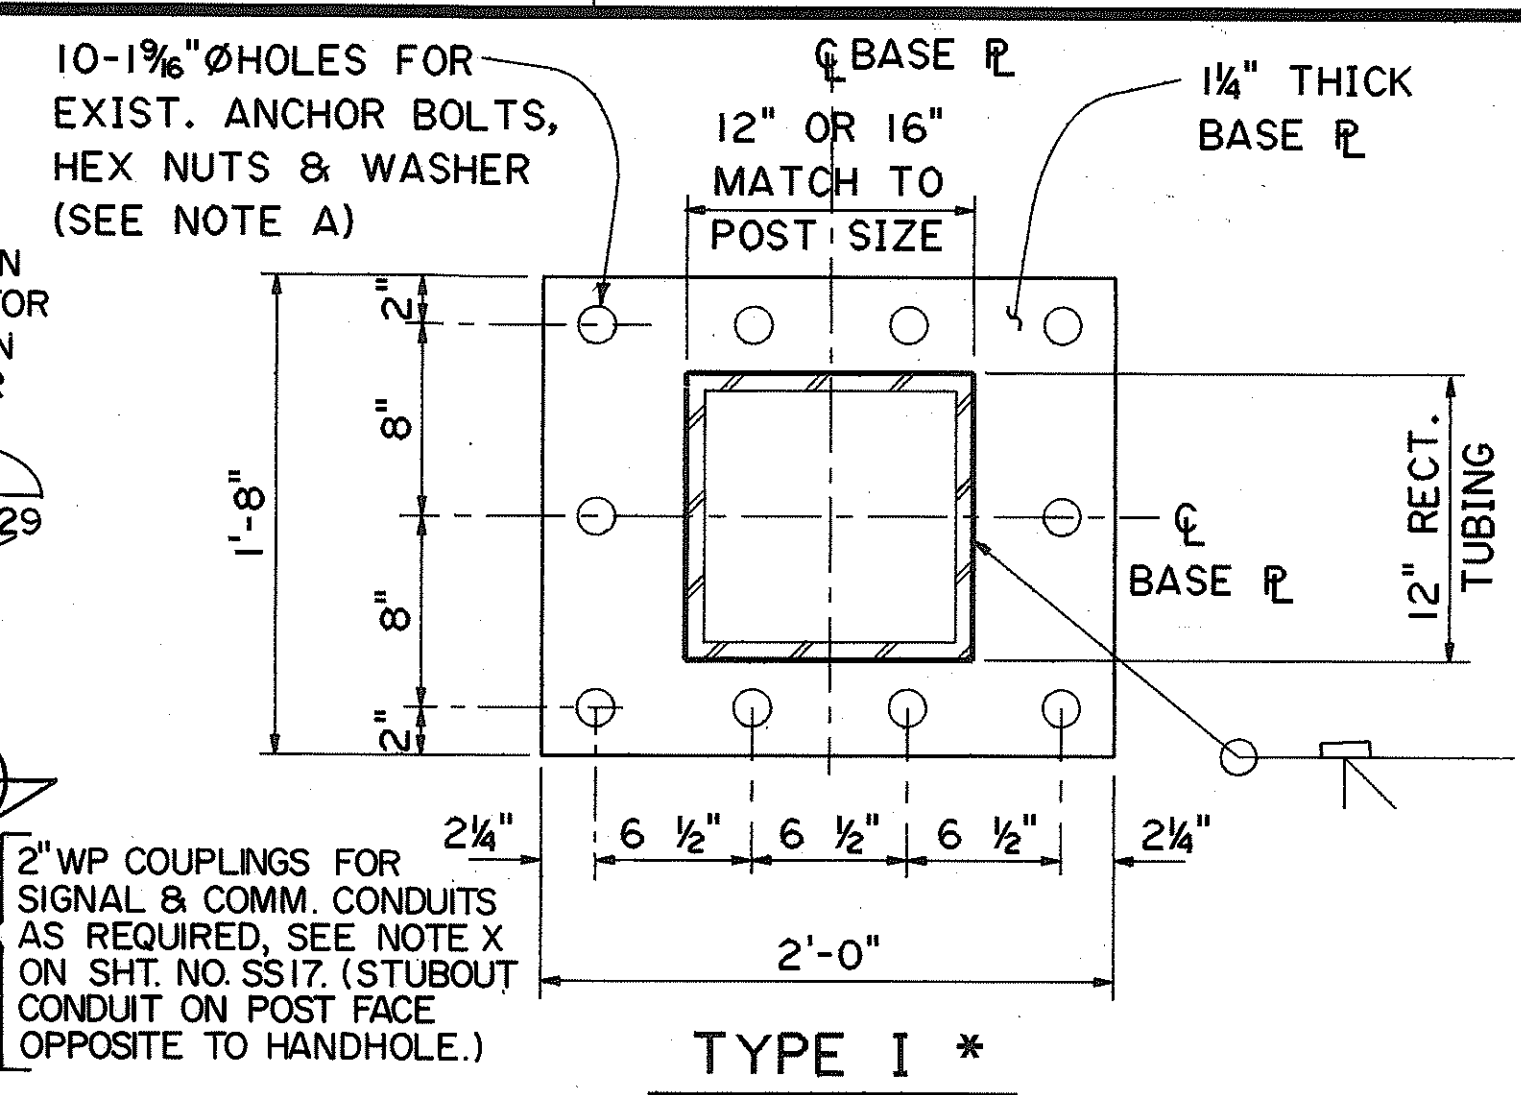

* FOR I.B. STA. 257+51, 258+66, 261+70, 273+73.70, 275+74.70, 297+57.20 & 656+52.67
O.B. STA. 258+40, 261+40, 297+66.79, 304+39.28, 541+70.00 & 657+42.67


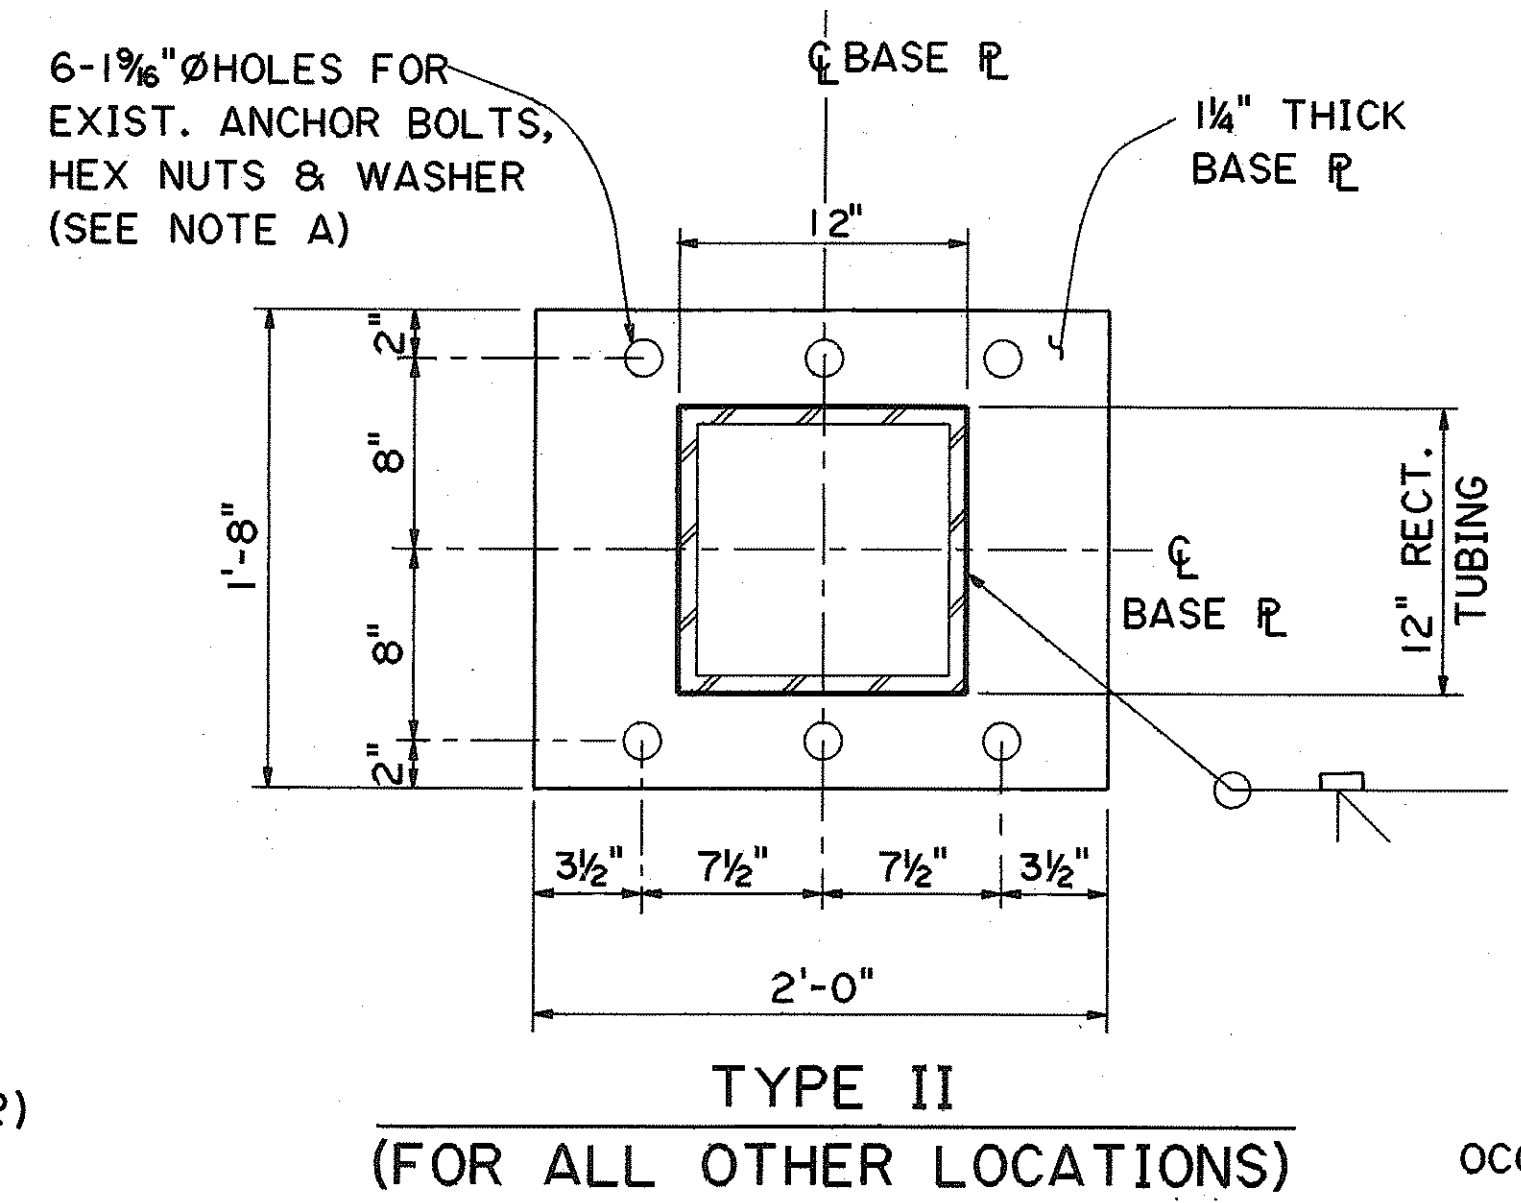


SECTION C
SS31 SS31

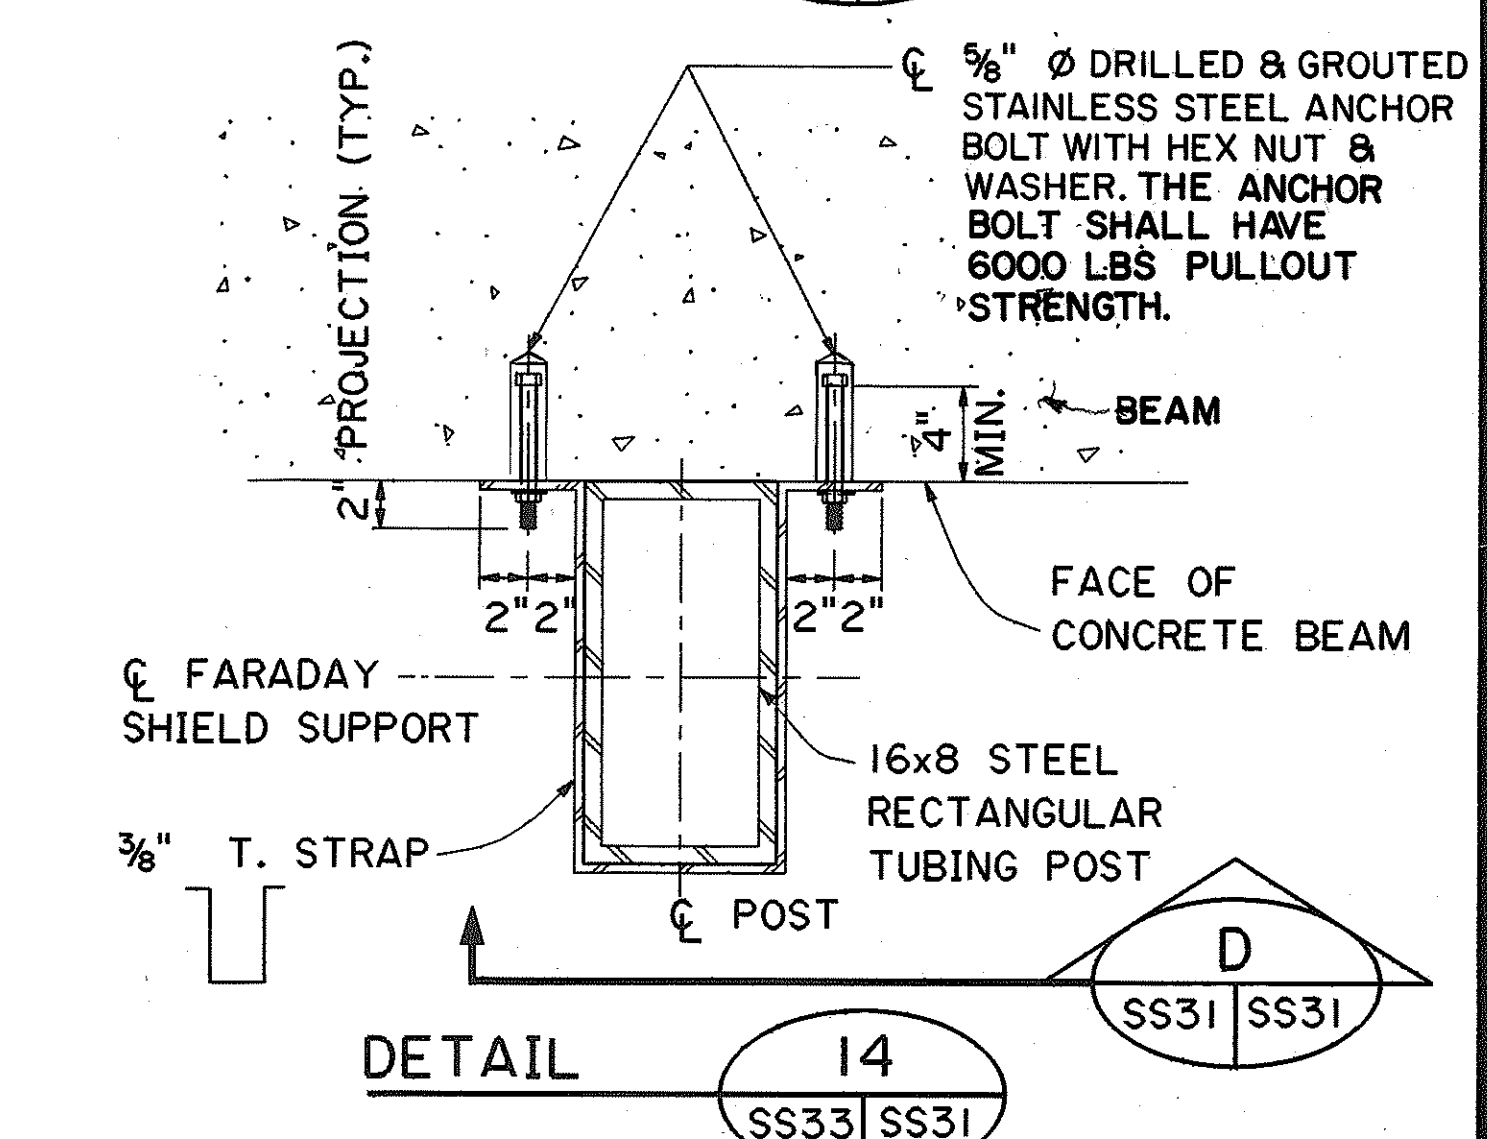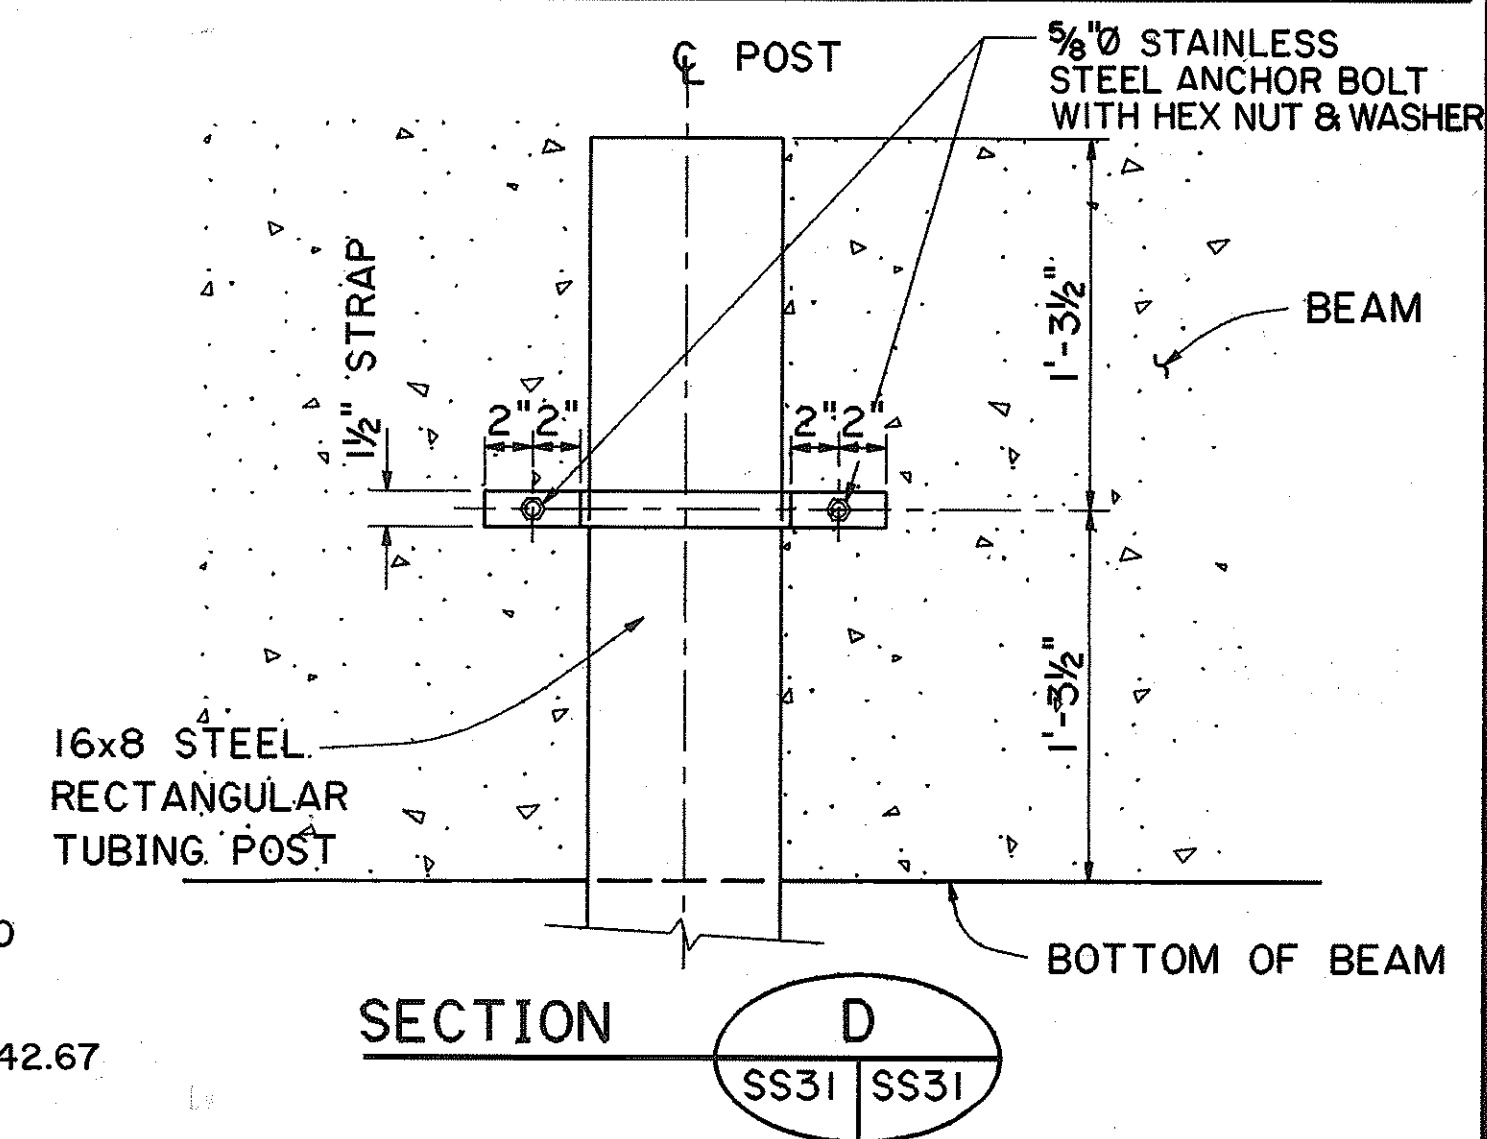

TOP CONNECTION DETAIL FOR TUBING POST AT TUNNEL PORTAL FACE
SCALE: 1 1/2" = 1'-0"


OCCURS AT I.B. STA. 656+52.67 BOTH POSTS
O.B. STA. 657+42.67 LEFT POST (LOOKING DOWNSTATION)

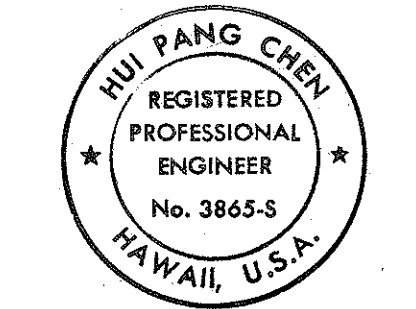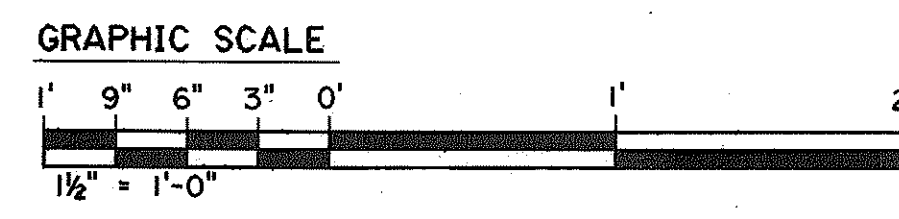


THIS WORK WAS PREPARED BY ME OR UNDER MY SUPERVISION
Hui Pang Chen

5-25-93	REVISED TYPE I BASE CONNECTION AND DETAIL 14 PER DCN 66-008
DATE	REVISION
STATE OF HAWAII DEPARTMENT OF TRANSPORTATION HIGHWAYS DIVISION	
MISCELLANEOUS DETAILS-3	
SUPPORT STRUCTURES INTERSTATE ROUTE H-3 F.A.I. PROJ. NO. I-H3-1(66)	
SCALE: AS SHOWN	DATE: APR. 1992
SHEET NO. SS31	OF 36 SHEETS


FED. ROAD DIST. NO.	STATE	FED. AID PROJ. NO.	FISCAL YEAR	SHEET NO.	TOTAL SHEETS
HAWAII	HAW.	I-H3-I(66)	1992	394	440

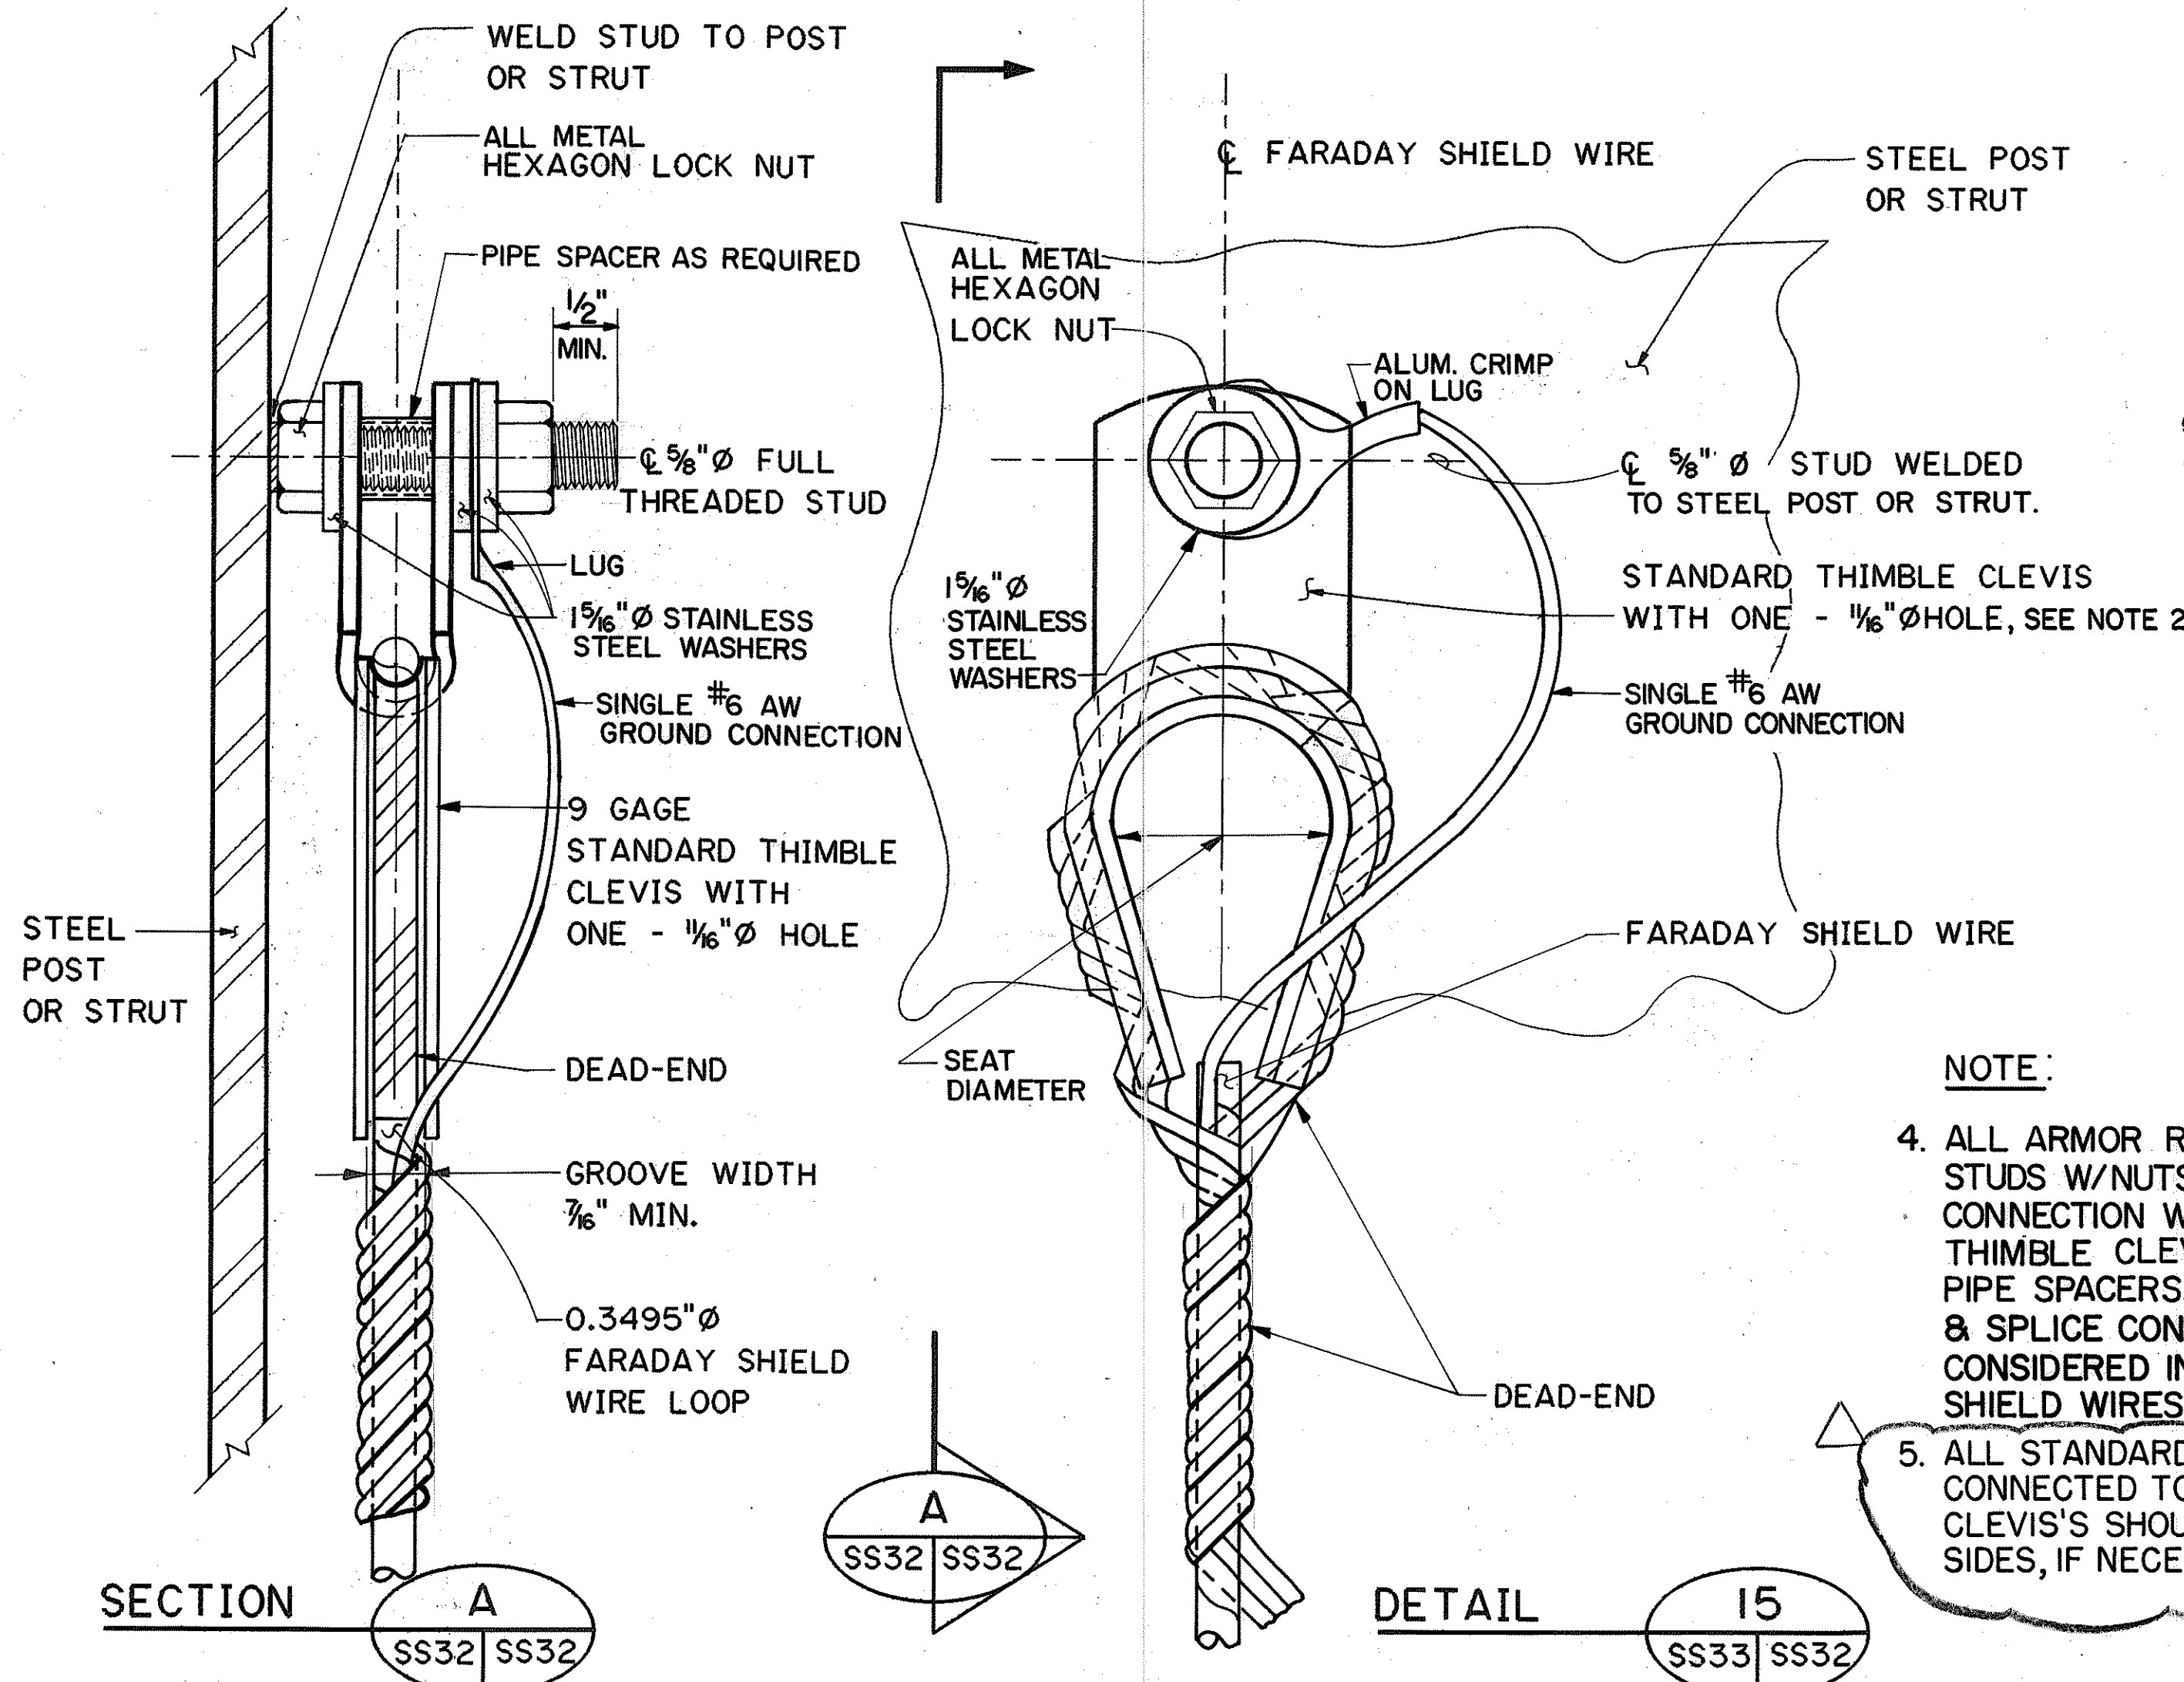

TYPICAL FARADAY SHIELD WIRE DEAD-END CONNECTION TO STEEL
N.T.S.

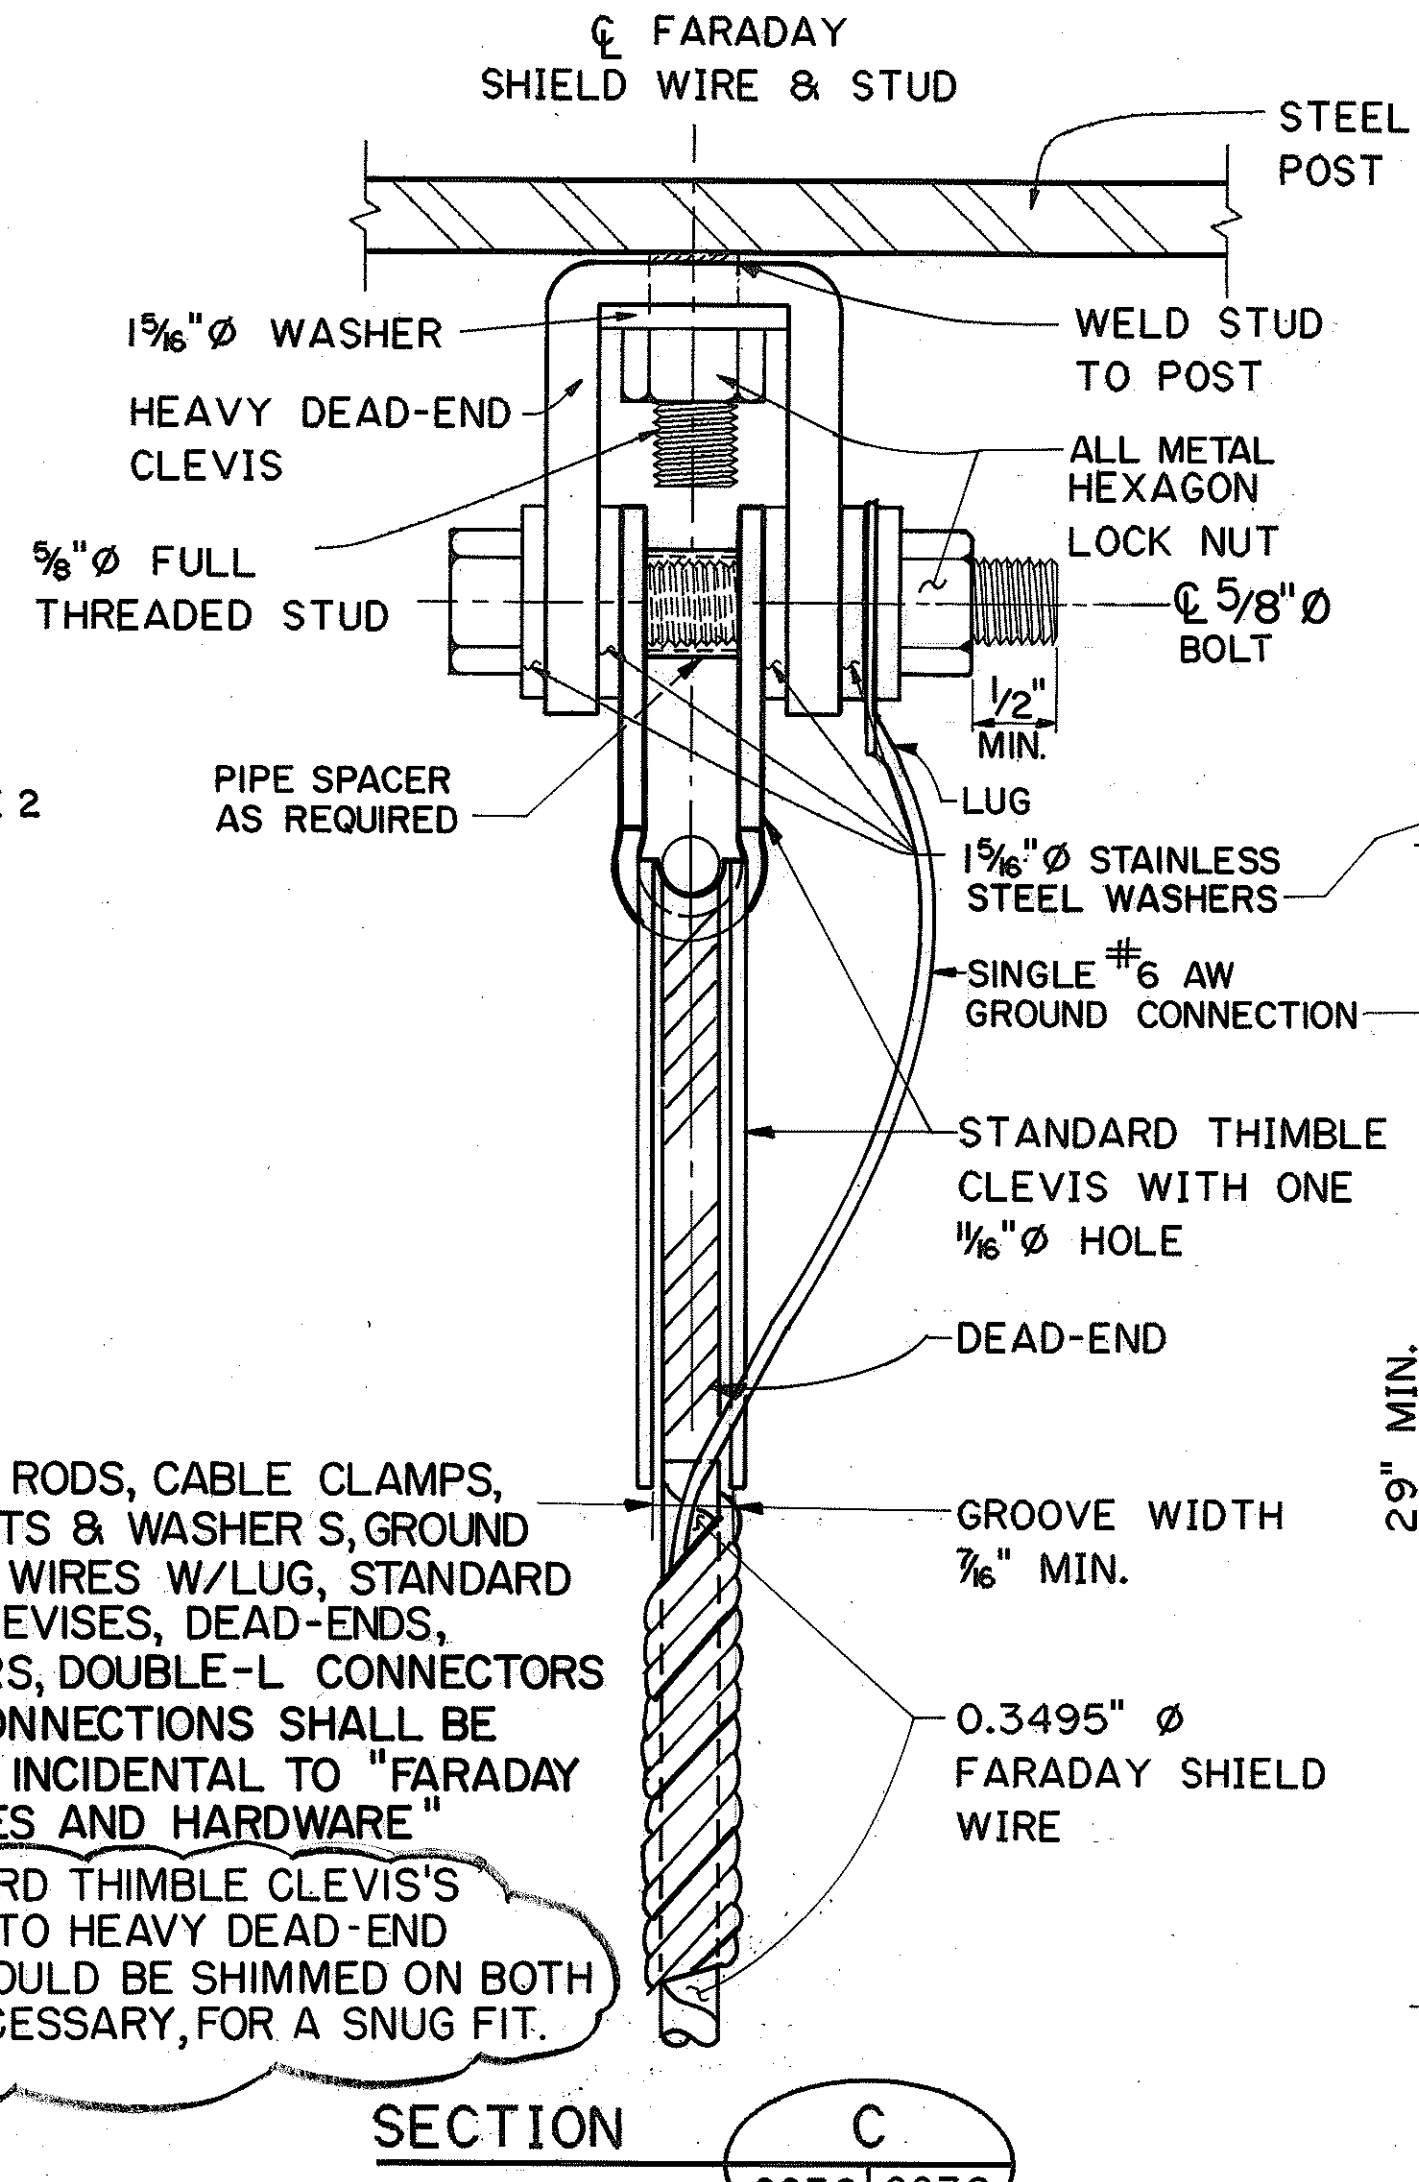


FARADAY SHIELD WIRE ANGLED DEAD-END CONNECTION TO STEEL
N.T.S.

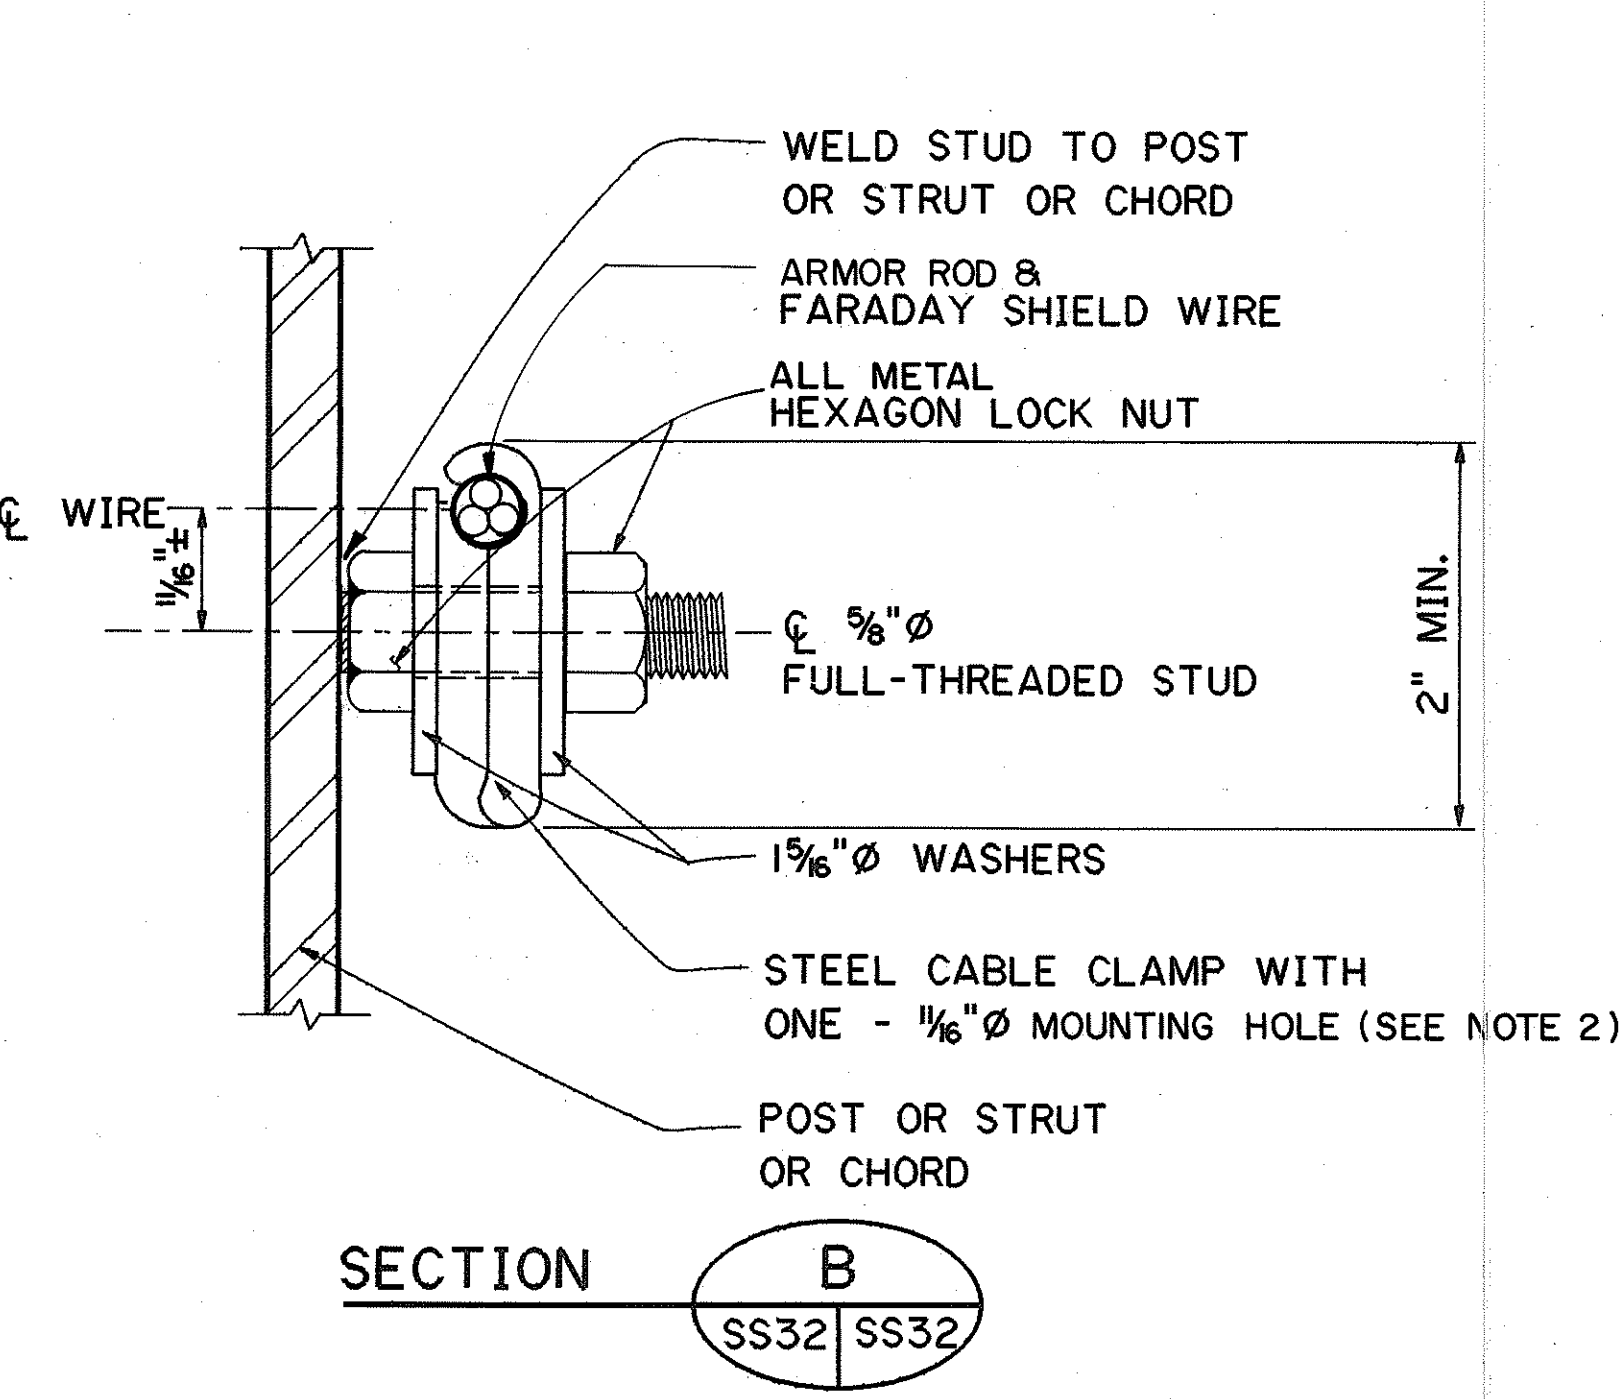


TYPICAL THROUGH FARADAY SHIELD WIRE CONNECTION
N.T.S.

- NOTES:
1. ALL FARADAY SHIELD WIRES, DEADENDS & STRAND SPLICES SHALL BE ALUMINUM-CLAD STEEL WIRES.
 2. ALL HARDWARES CONNECTING FARADAY SHIELD WIRES SHALL BE HOT-DIP GALVANIZED STEEL. ALL HARDWARE SHALL DEVELOP A MIN. BREAKING STRENGTH OF 5000 LBS.
 3. DEAD ENDS & STRAND SPLICES SHALL DEVELOP A MIN. ULT. HOLDING STRENGTH OF 10,280 LBS.

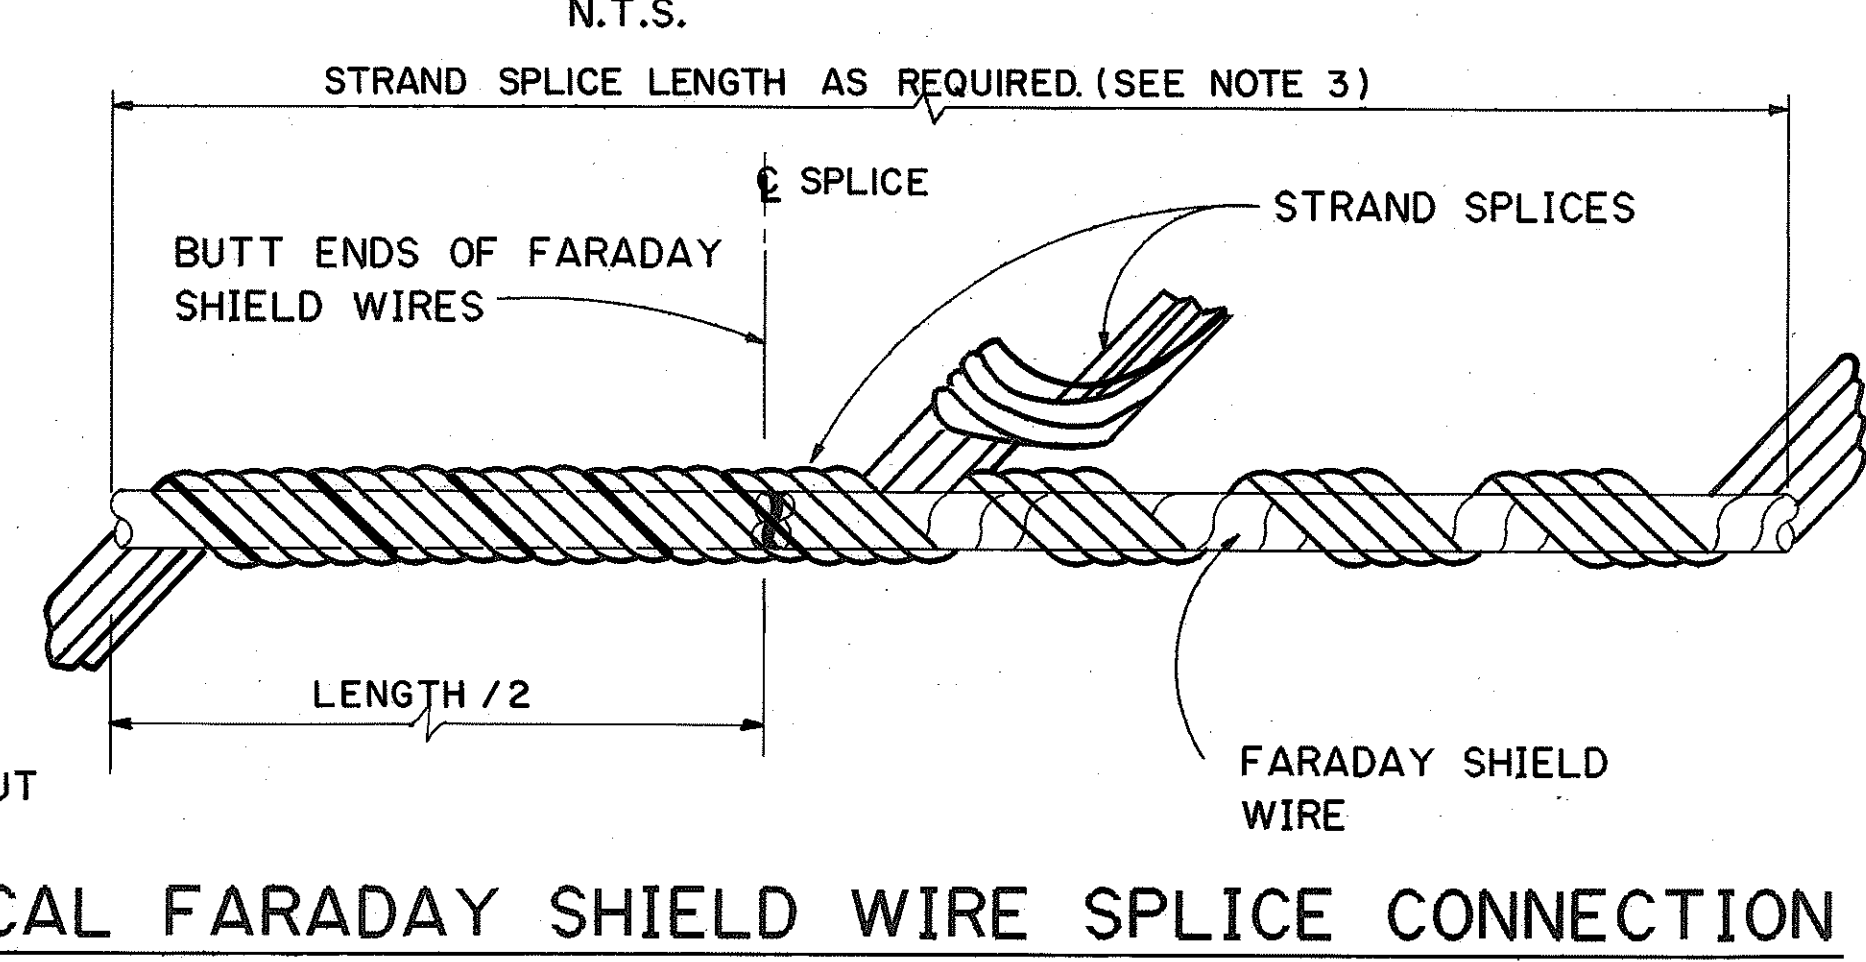

TYPICAL FARADAY SHIELD WIRE SPLICE CONNECTION
N.T.S.

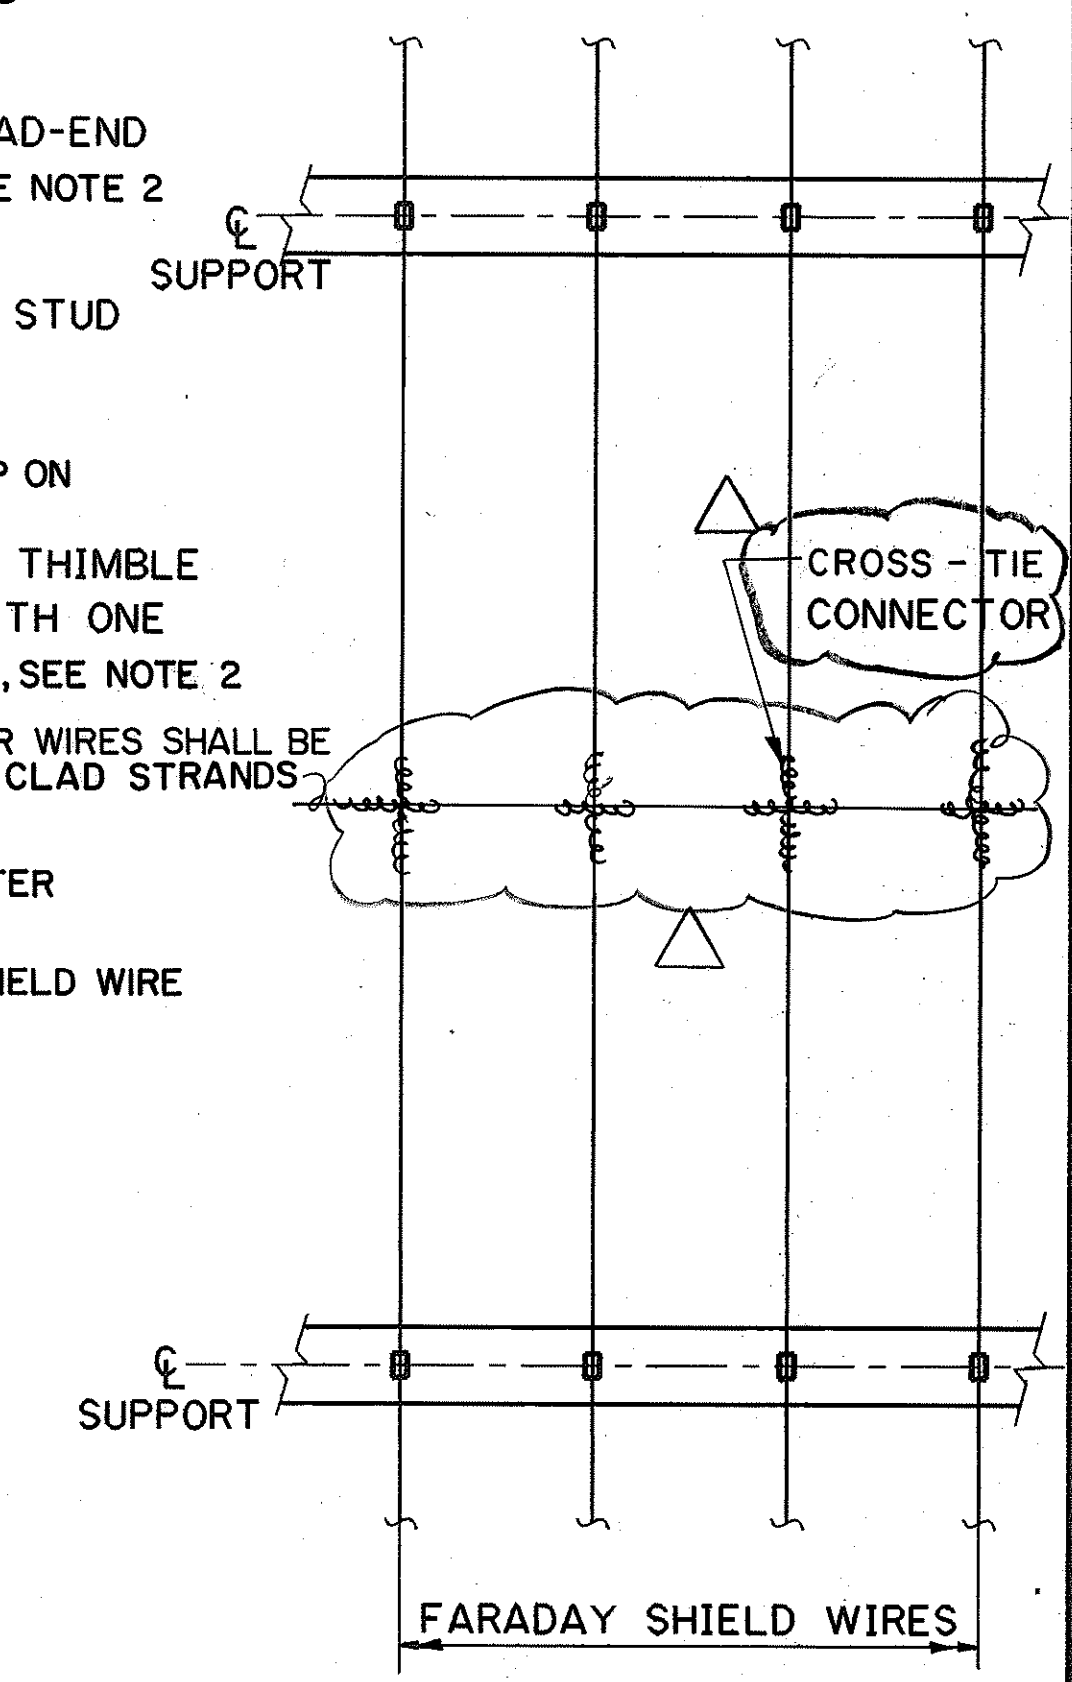




PLAN-TYPICAL FARADAY SHIELD WIRE SPACER
N.T.S.

* OCCURS AT SPANS SHOWN IN TABLE A SHEET SS3.




5-25-93	REVISED PLAN-TYPICAL FARADAY SHIELD WIRE SPACER & DETAIL 16; ADDED NOTE 5 PER DCN 66-008
DATE	REVISION
STATE OF HAWAII DEPARTMENT OF TRANSPORTATION HIGHWAYS DIVISION	
MISCELLANEOUS DETAILS-4	
SUPPORT STRUCTURES INTERSTATE ROUTE H-3 F.A.I. PROJ. NO. I-H3-I(66)	
SCALE: AS SHOWN	DATE: APR. 1992
SHEET NO. SS32	OF 36 SHEETS

HUI PANG CHEN
REGISTERED PROFESSIONAL ENGINEER
No. 3865-S
HAWAII, U.S.A.
THIS WORK WAS PREPARED BY ME OR UNDER MY SUPERVISION
Hui Pang Chen

FED. ROAD DIST. NO.	STATE	FED. AID PROJ. NO.	FISCAL YEAR	SHEET NO.	TOTAL SHEETS
HAWAII	HAW.	I-H3-1(66)	1992	395	440

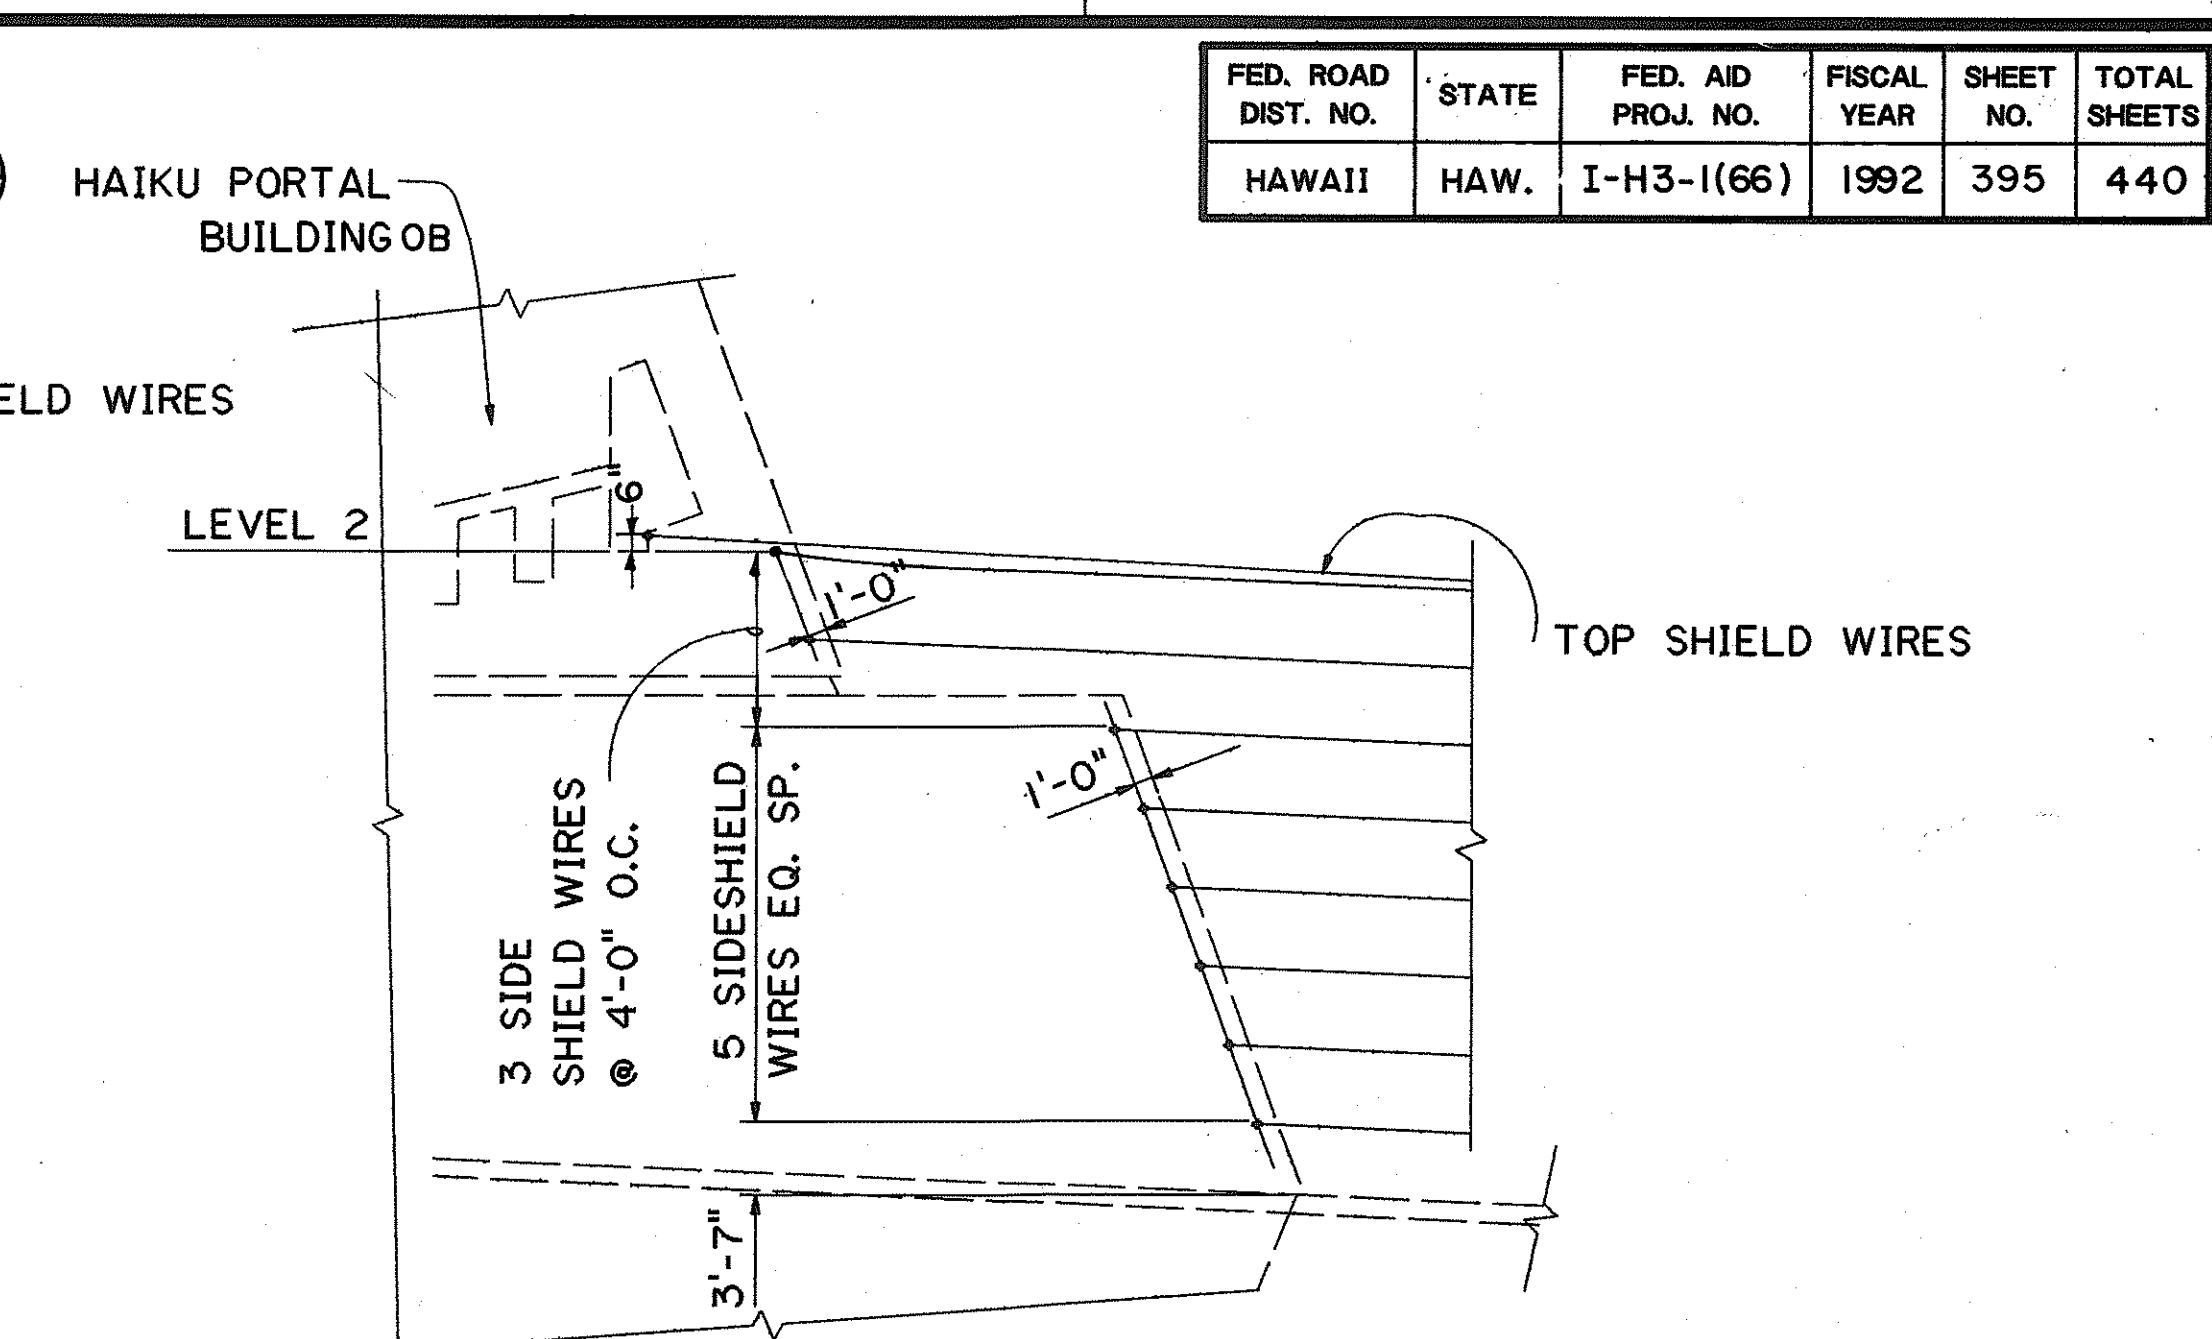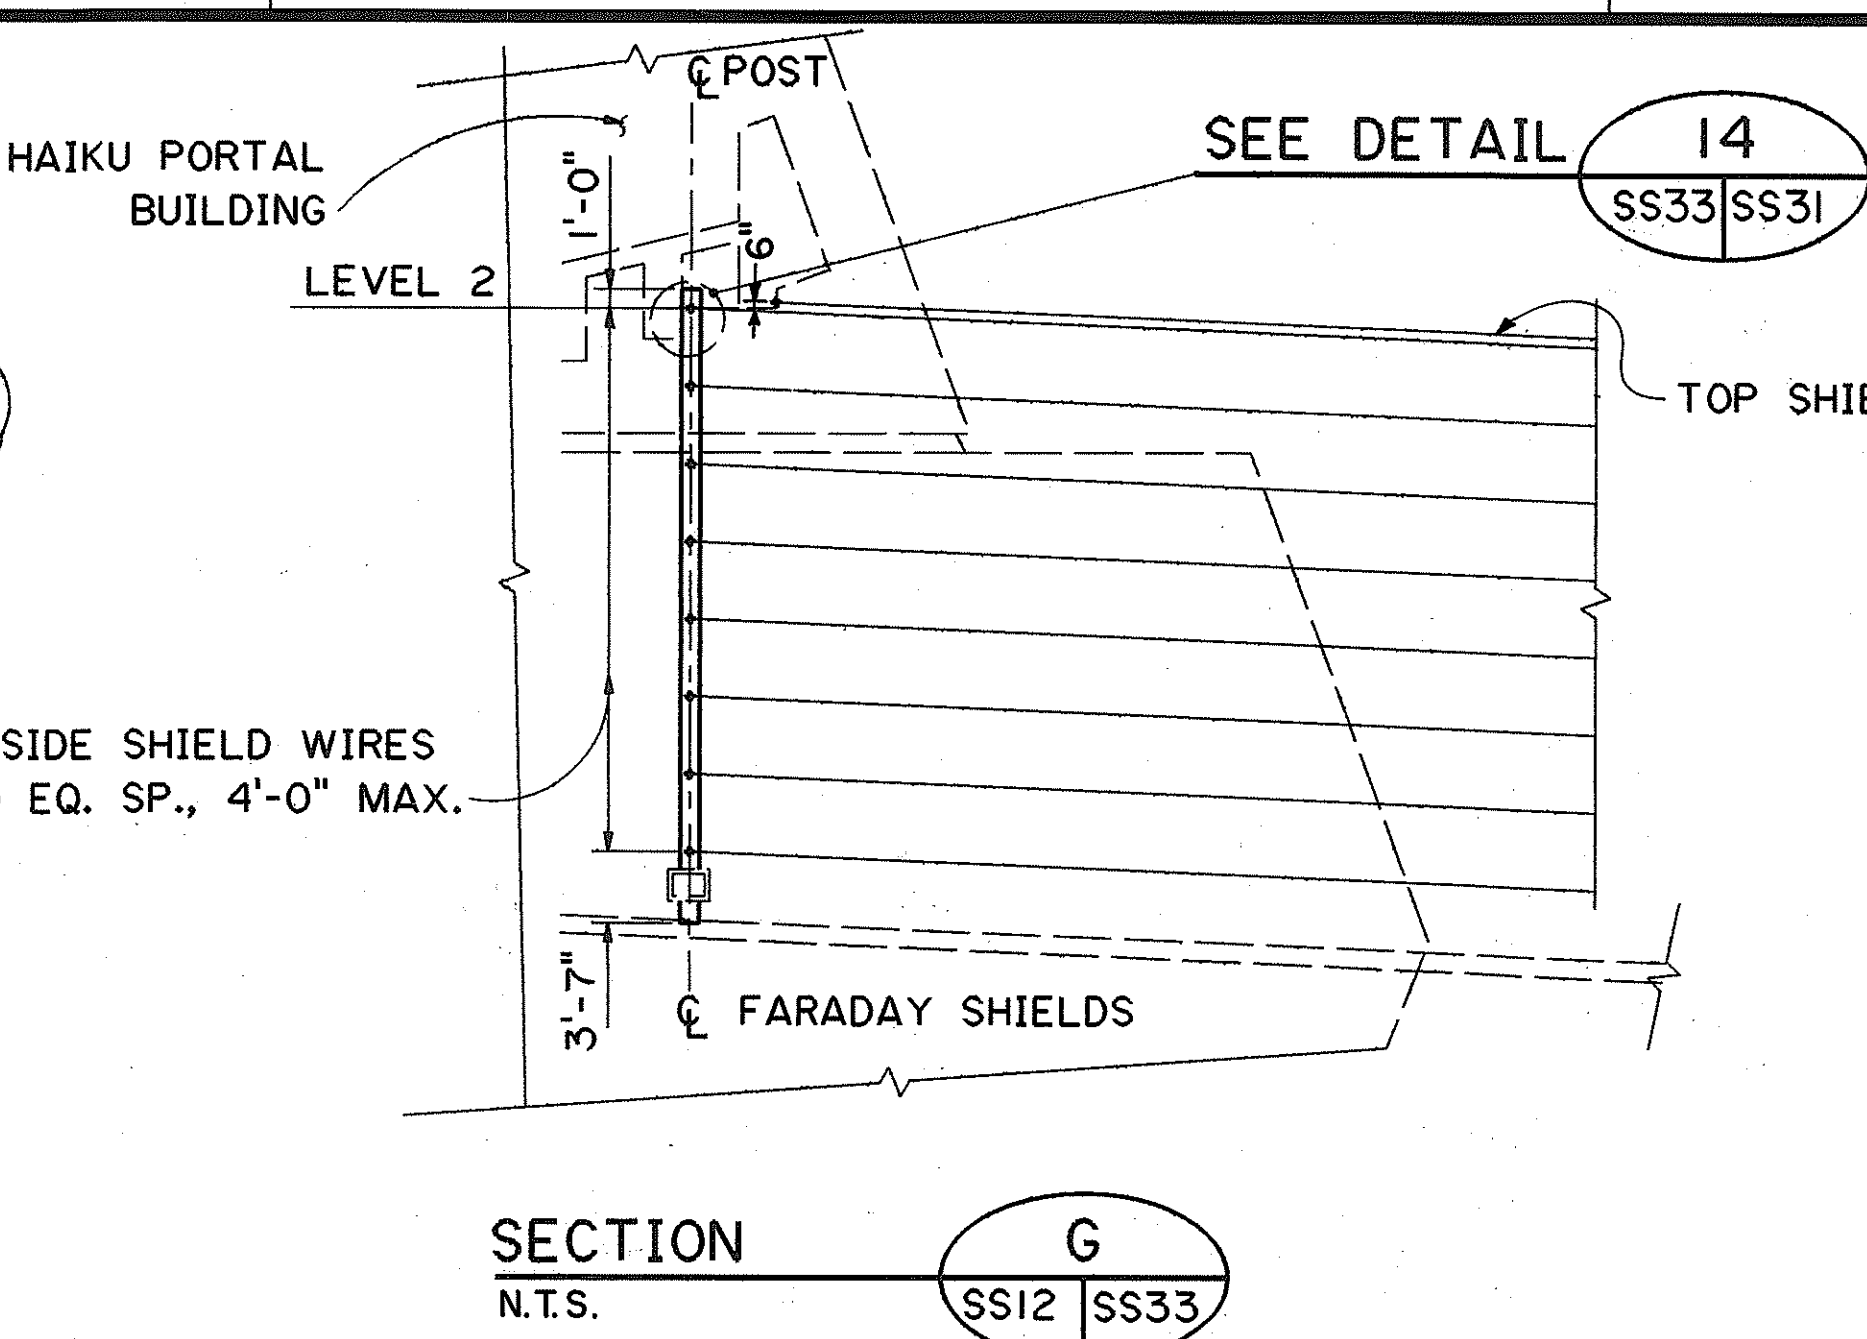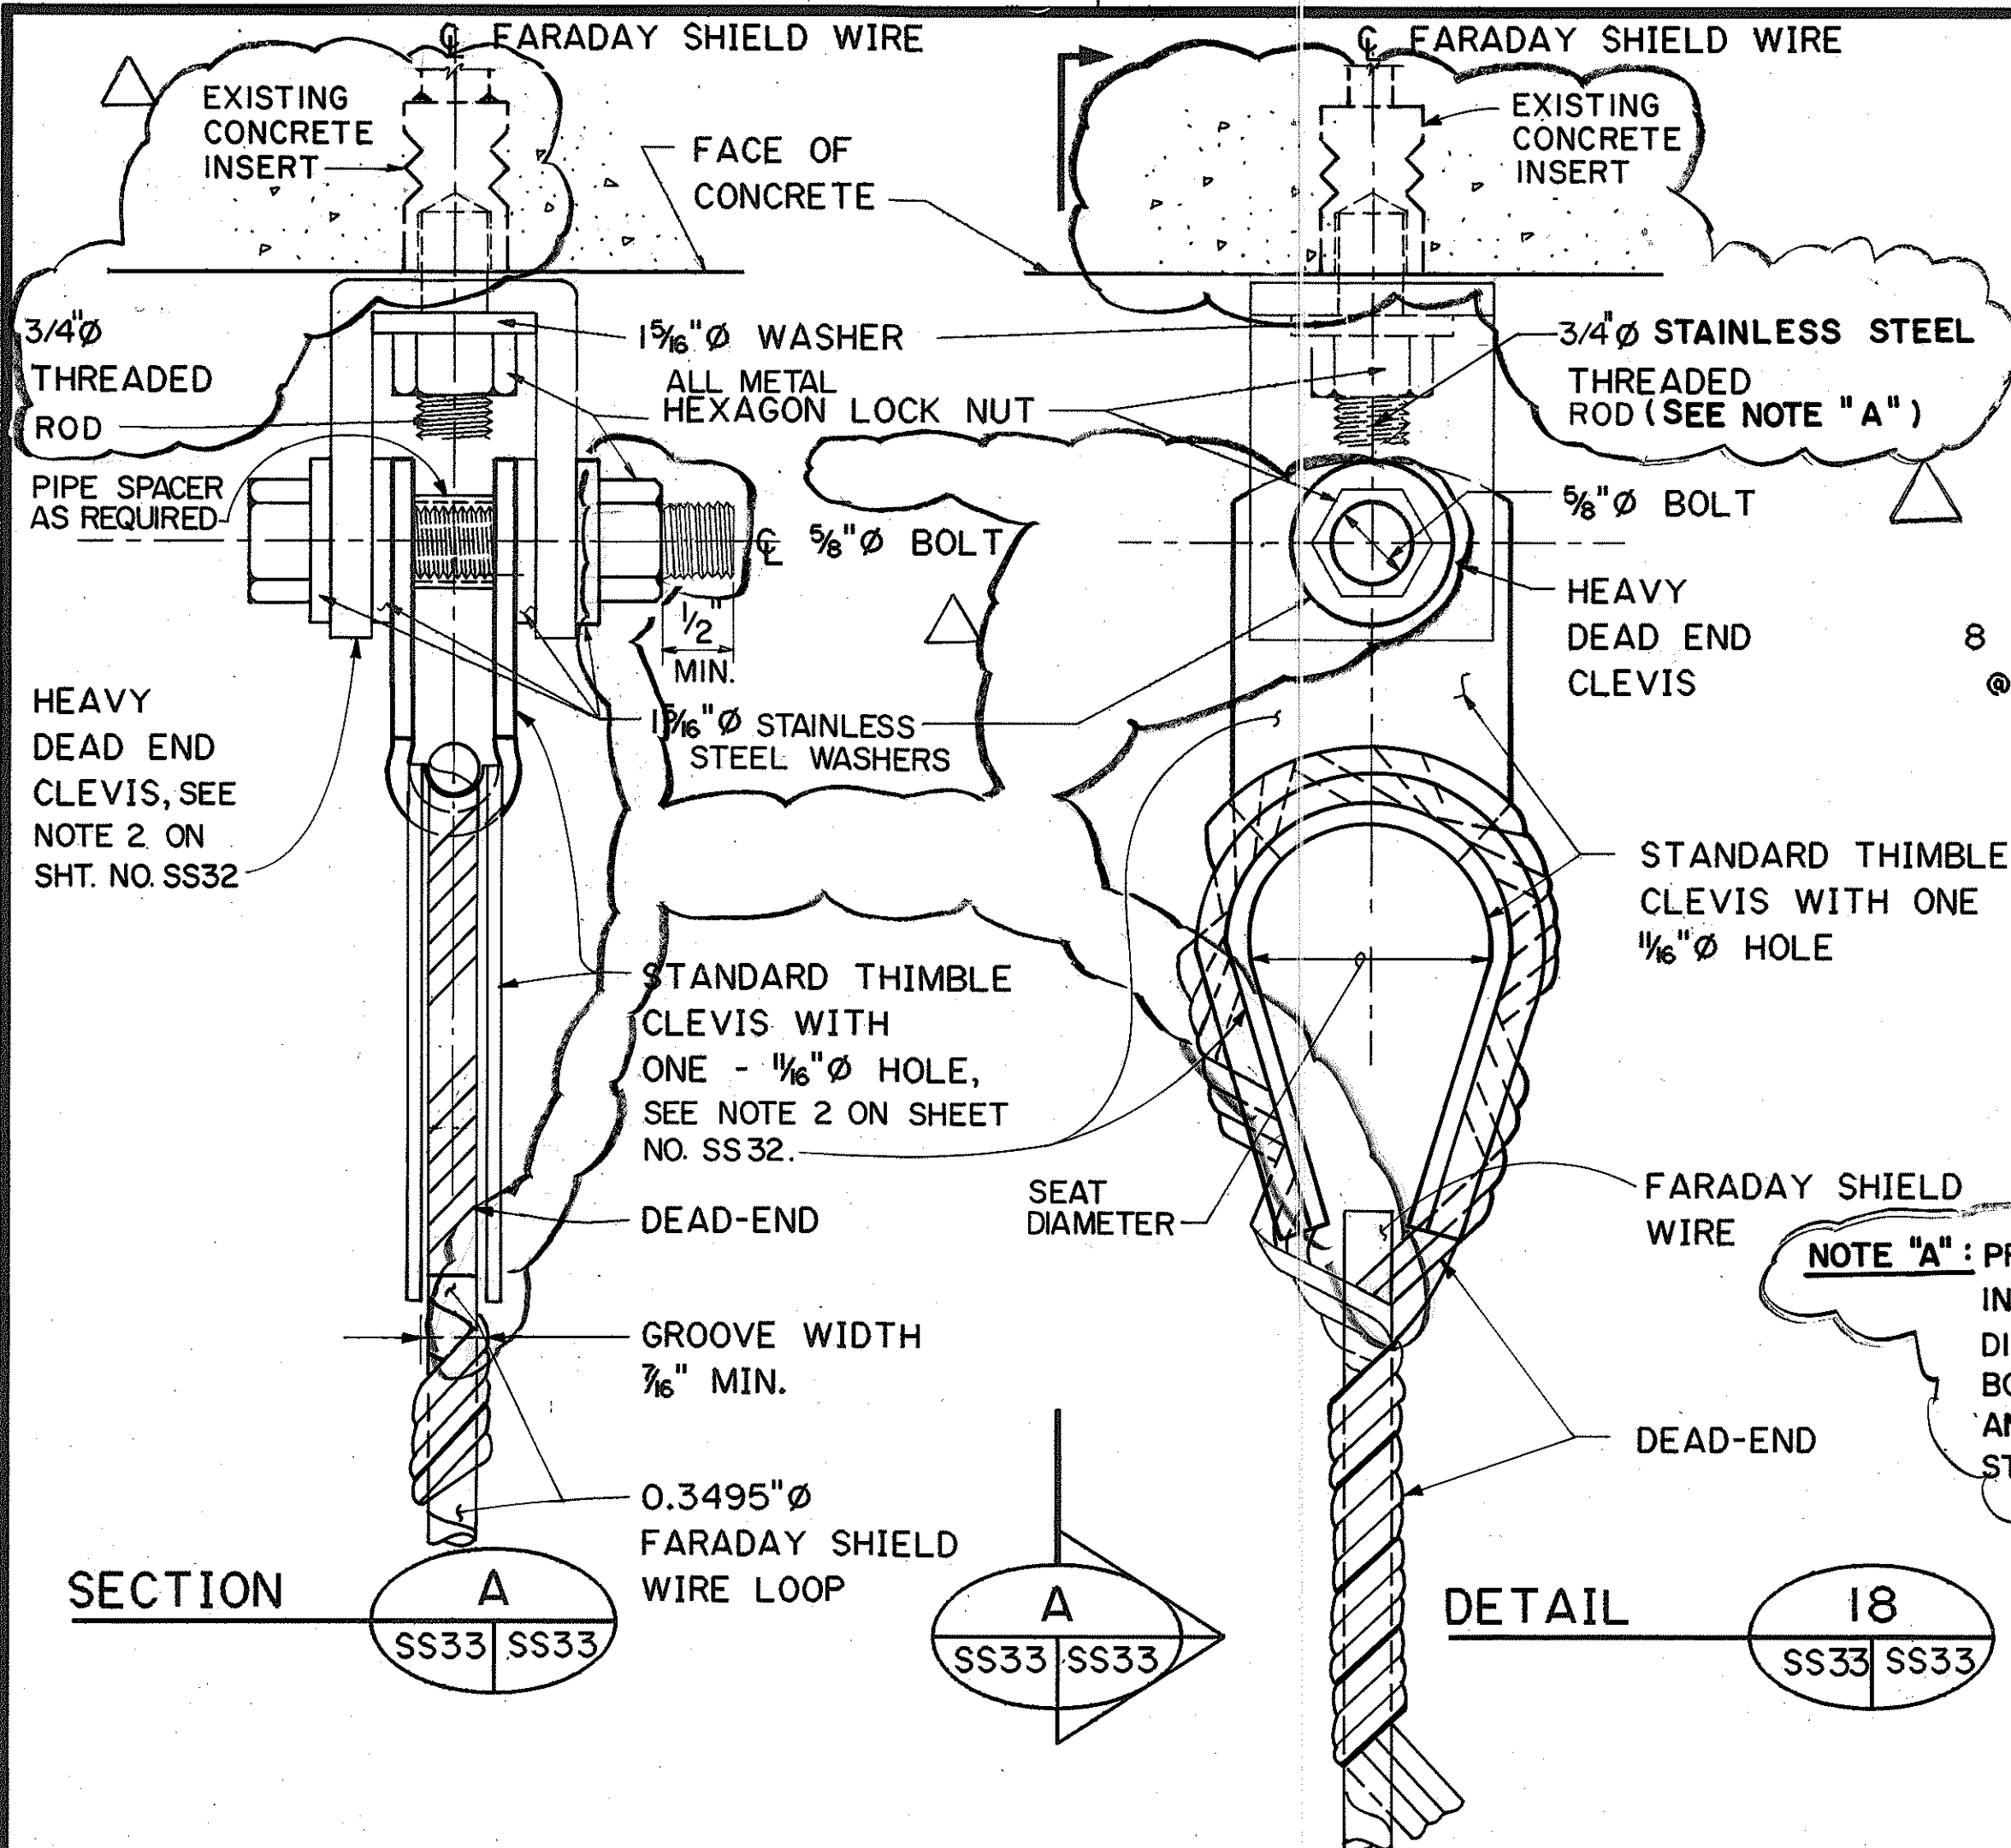

TYPICAL FARADAY SHIELD WIRE DEAD-END CONNECTION TO CONCRETE

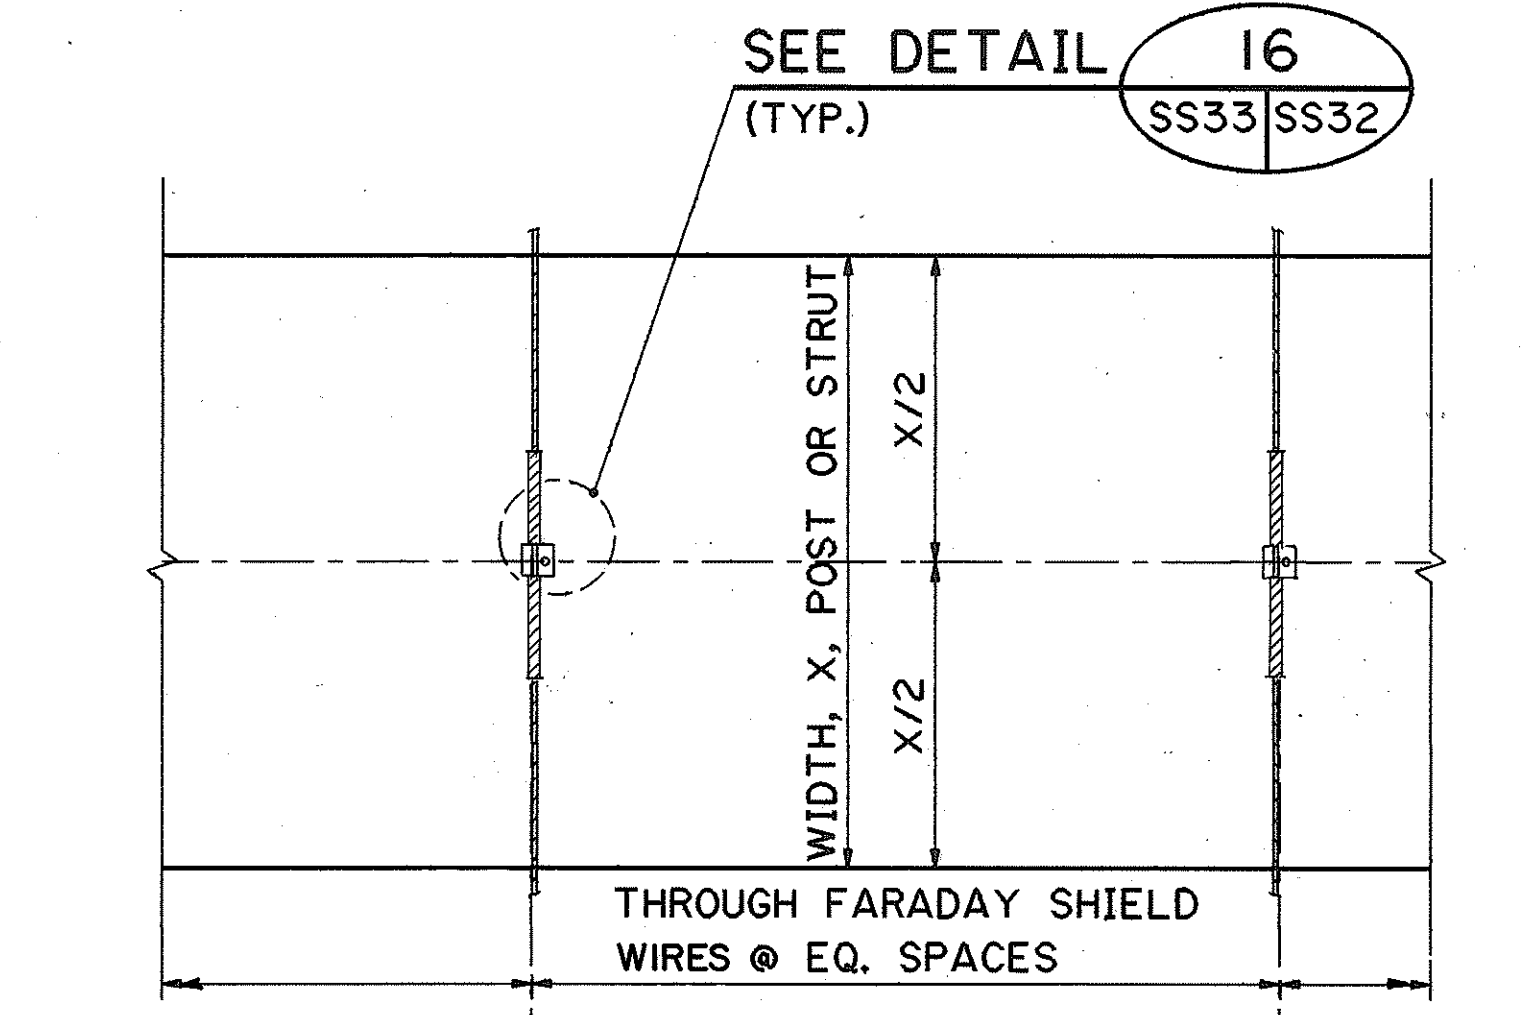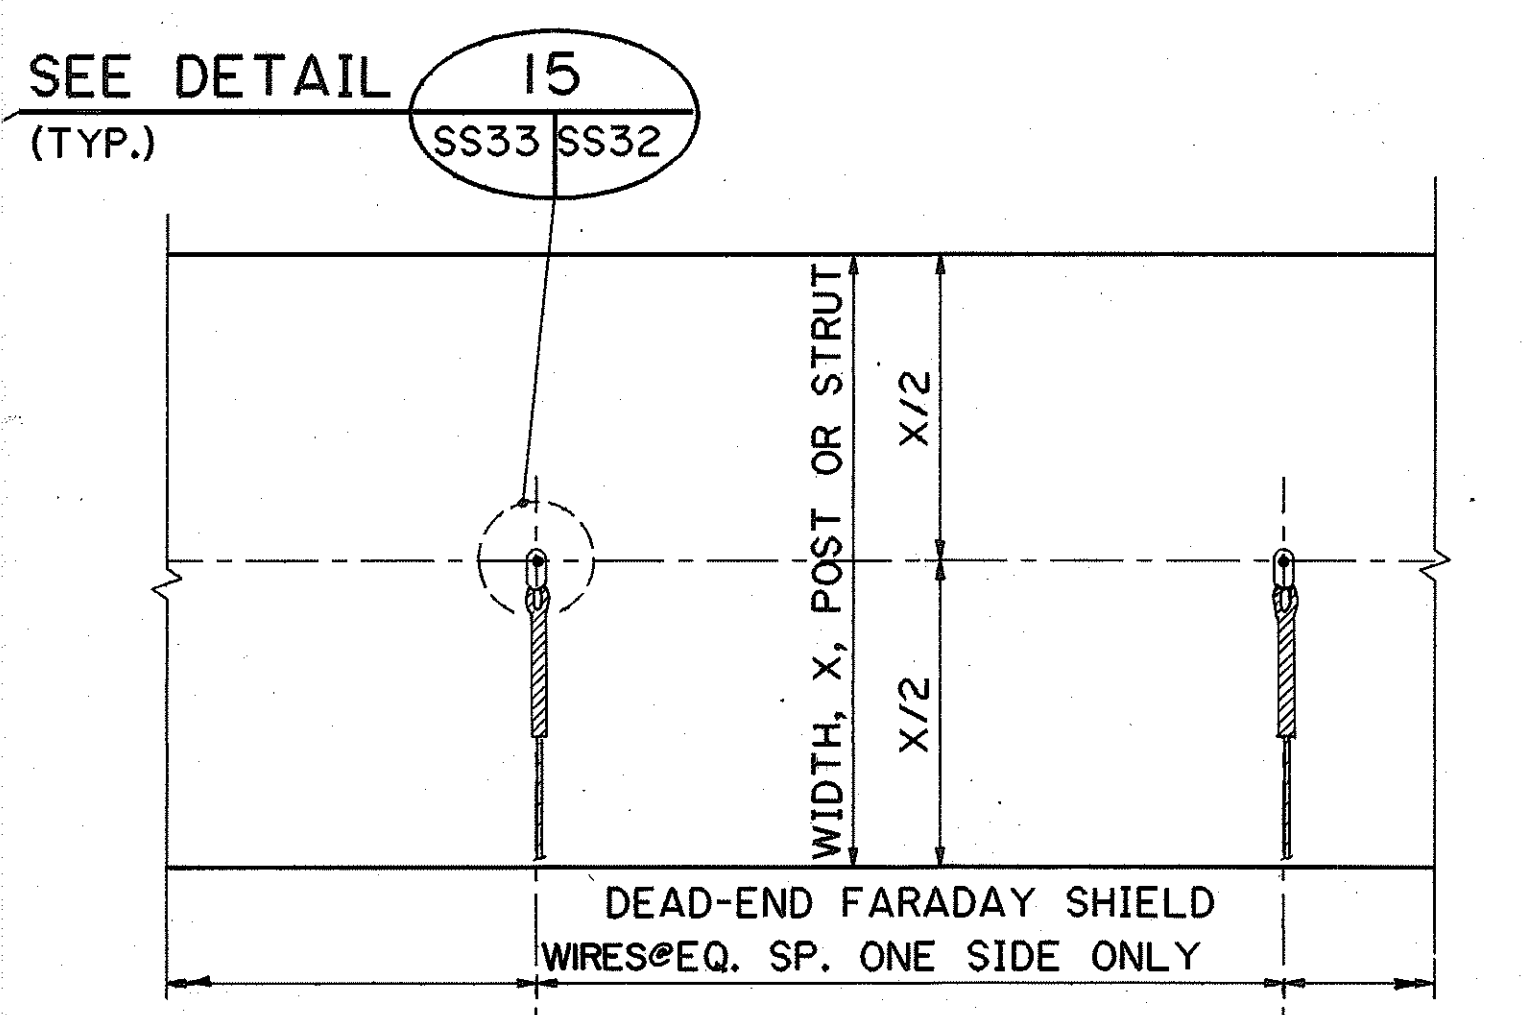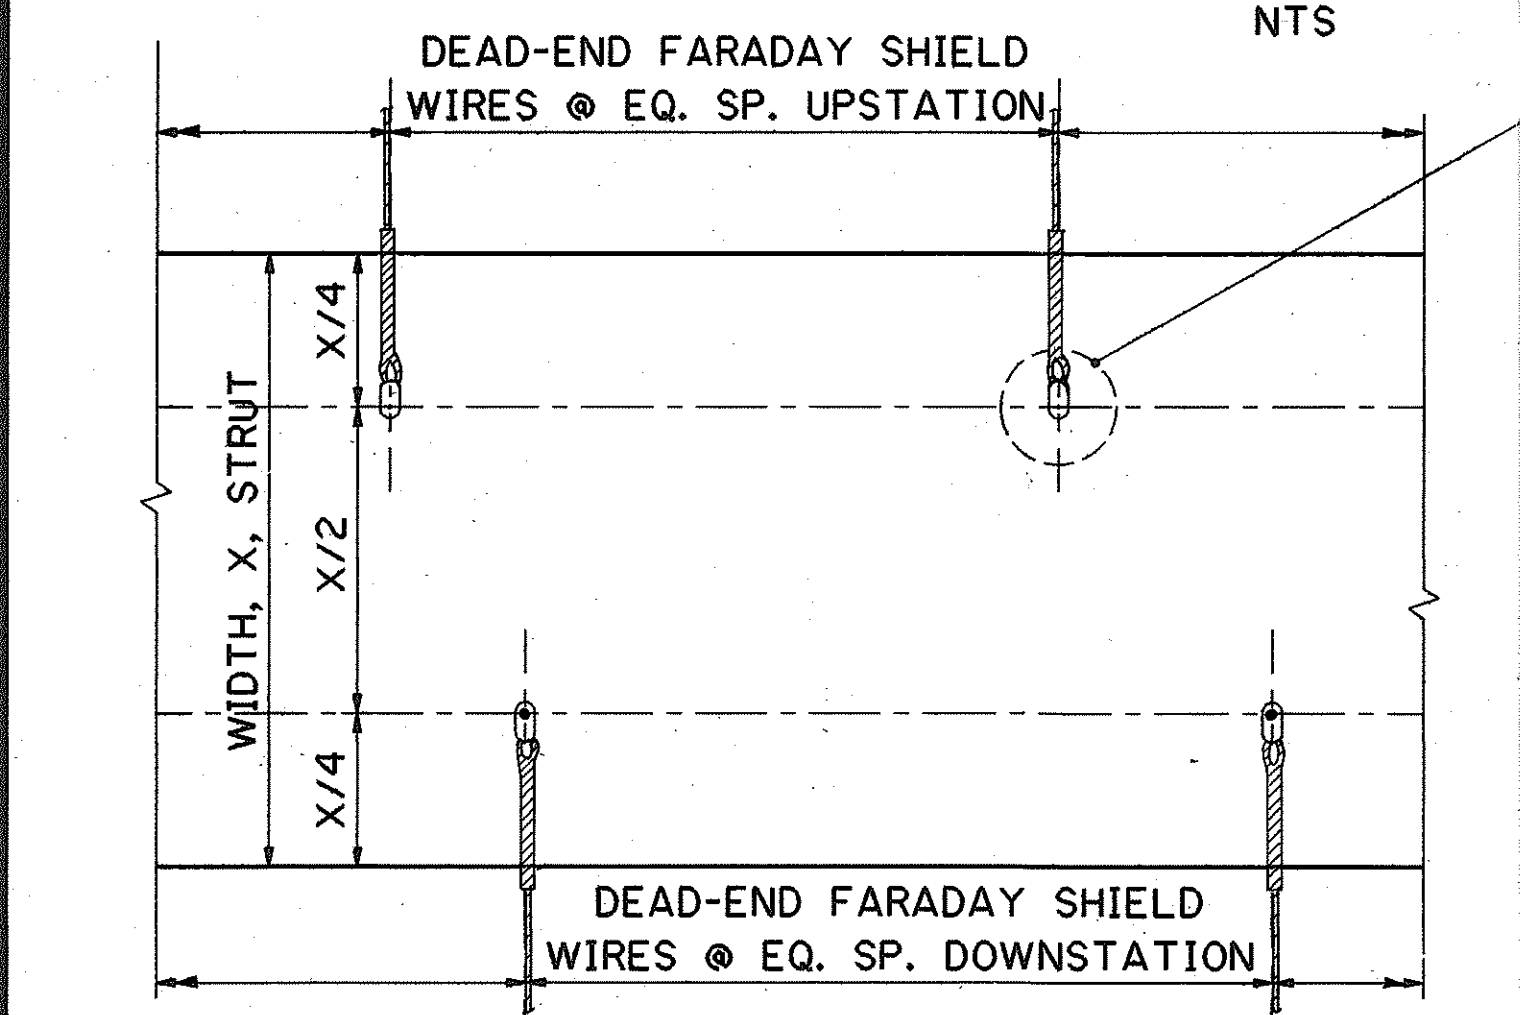

TYPE I UNBALANCED CONNECTION STRUT













OCCURS AT IB STA. 261+70.00, 262+58.75, 264+49.10, 265+34.70, 266+26.05
& OB. STA. 261+40.00 (OVER O.B. LANES), 262+41.99, 264+25.61, 265+13.11, 266+07.62, 290+34.28 & 294+03.28

TYPE II END CONNECTION-POST AND STRUT


STRUT OCCURS AT OB. STA. 261+40.00 (OVER SERVICE RD), & 264+25.61
POST* OCCURS AT IB STA. 656+52.67(LT&RT), 305+35.53 (LT&RT) & OB. STA. 657+42.67 (RT), 261+40.00(MIDDLE), & 305+40.11 (LT&RT).

TYPE III THROUGH CONNECTION-POST AND STRUT

AT ALL OTHER STATIONS

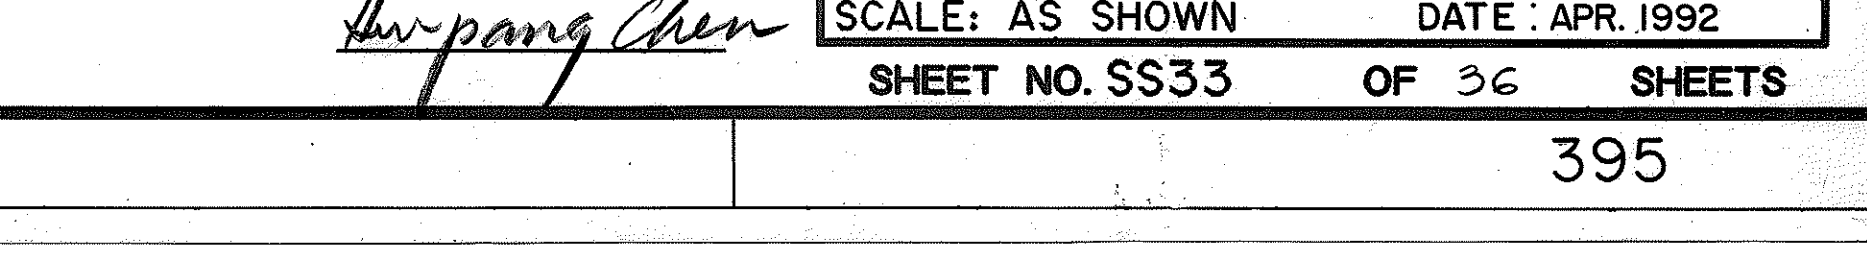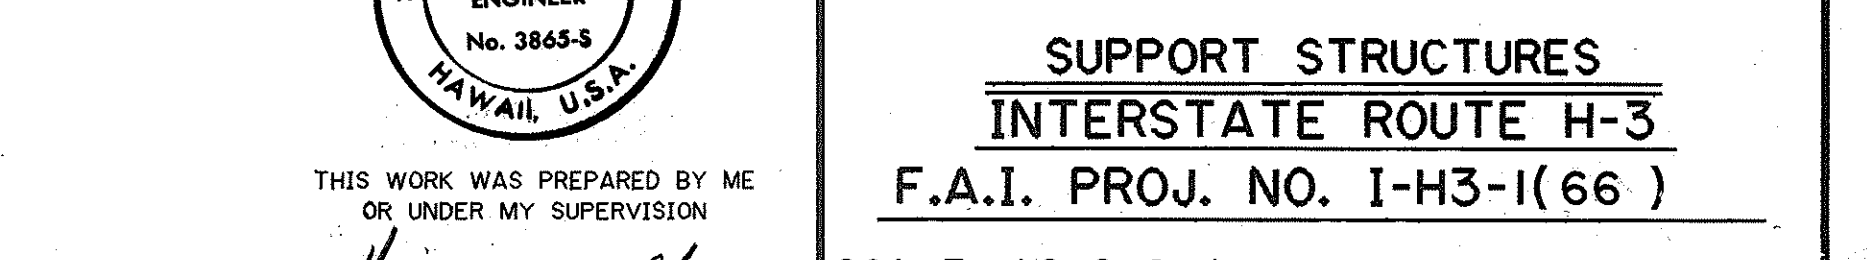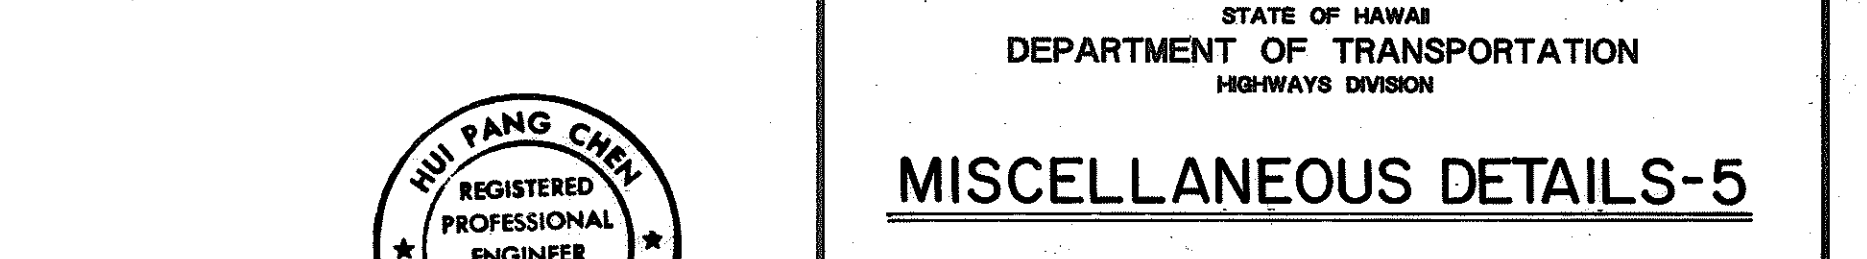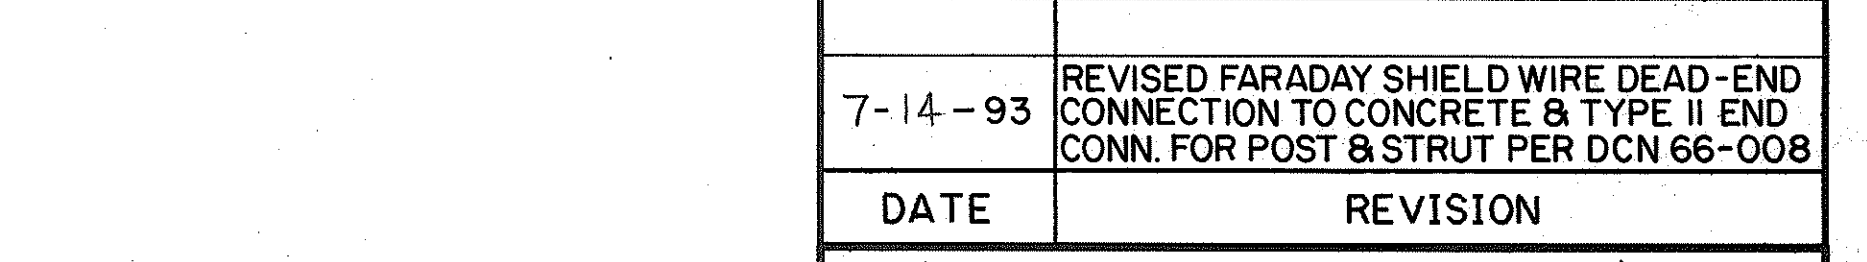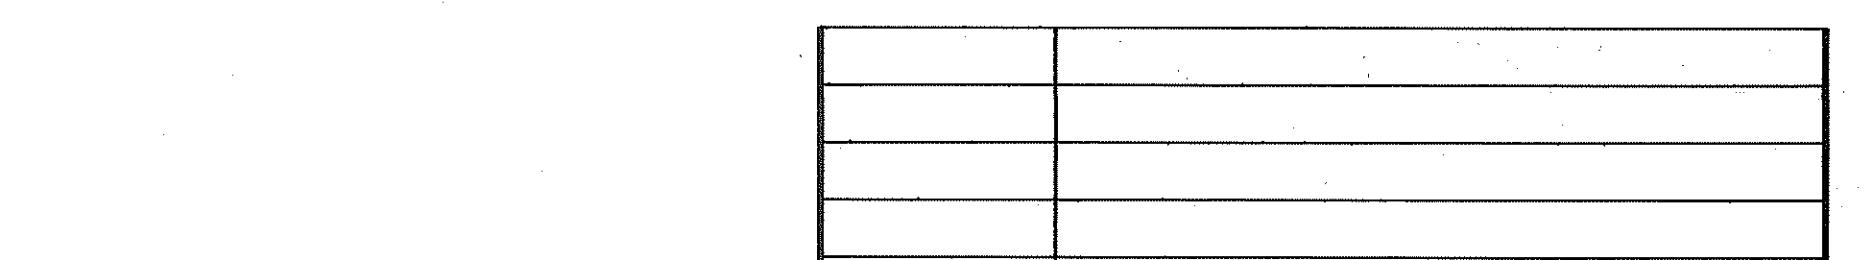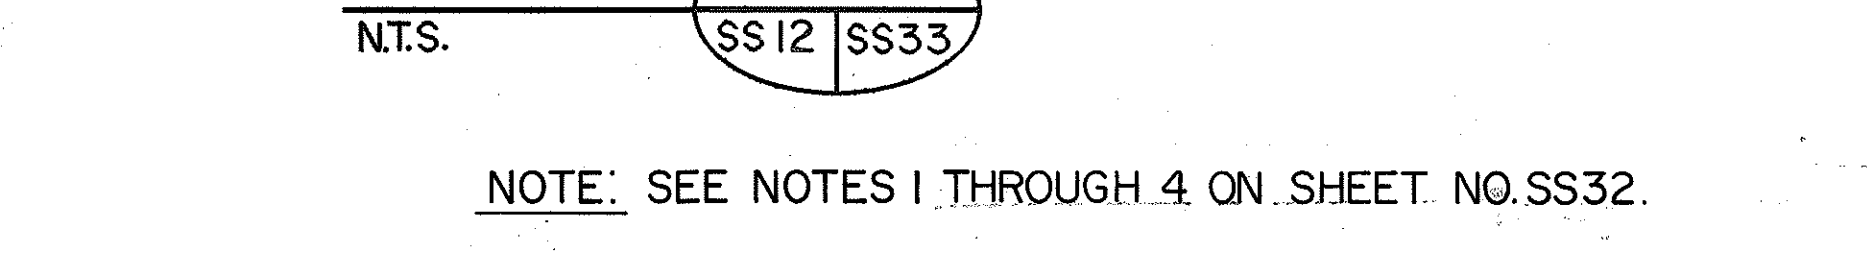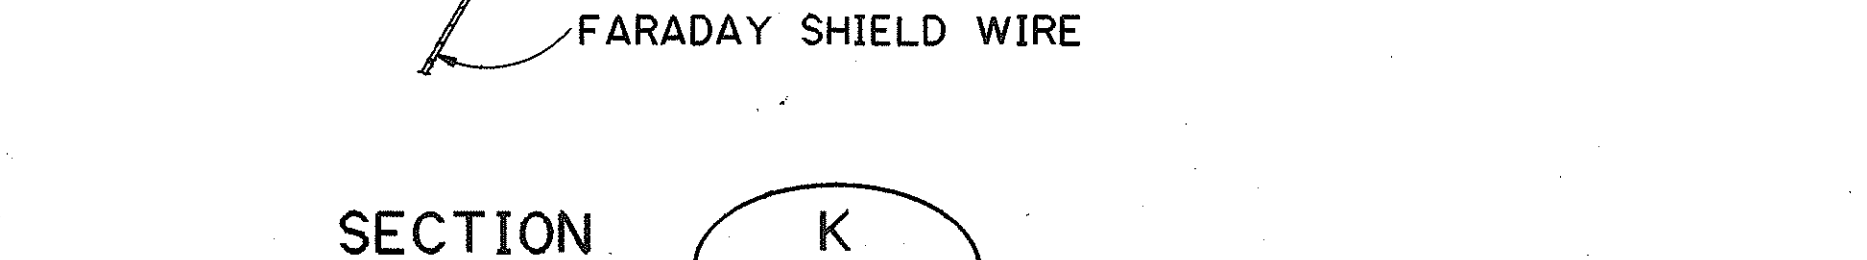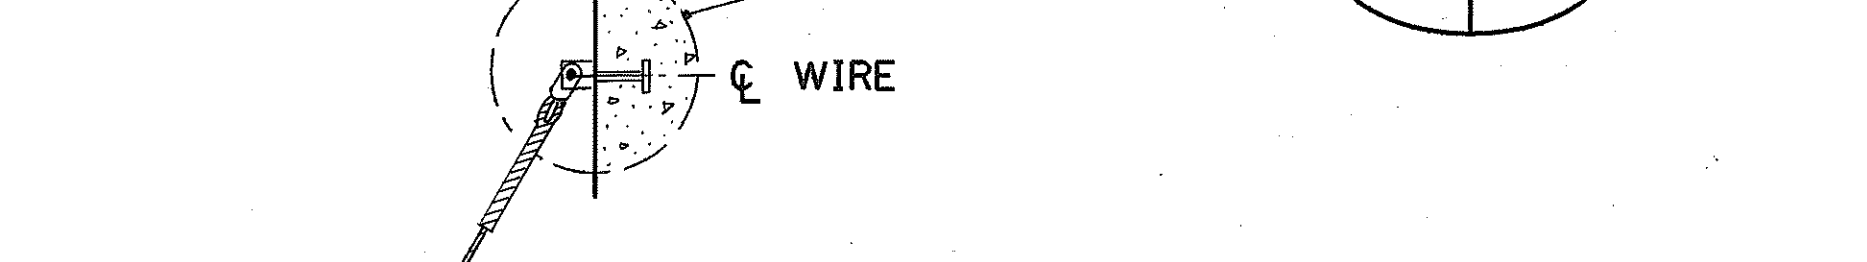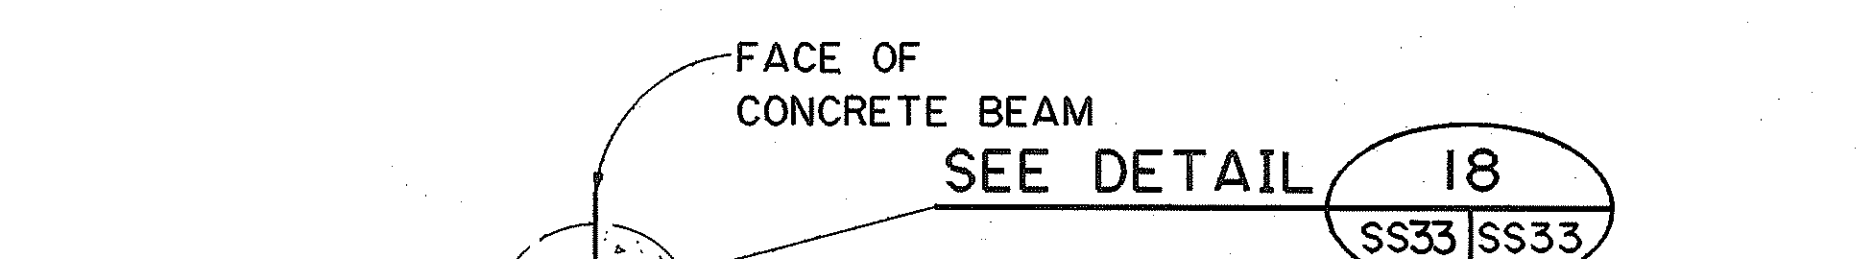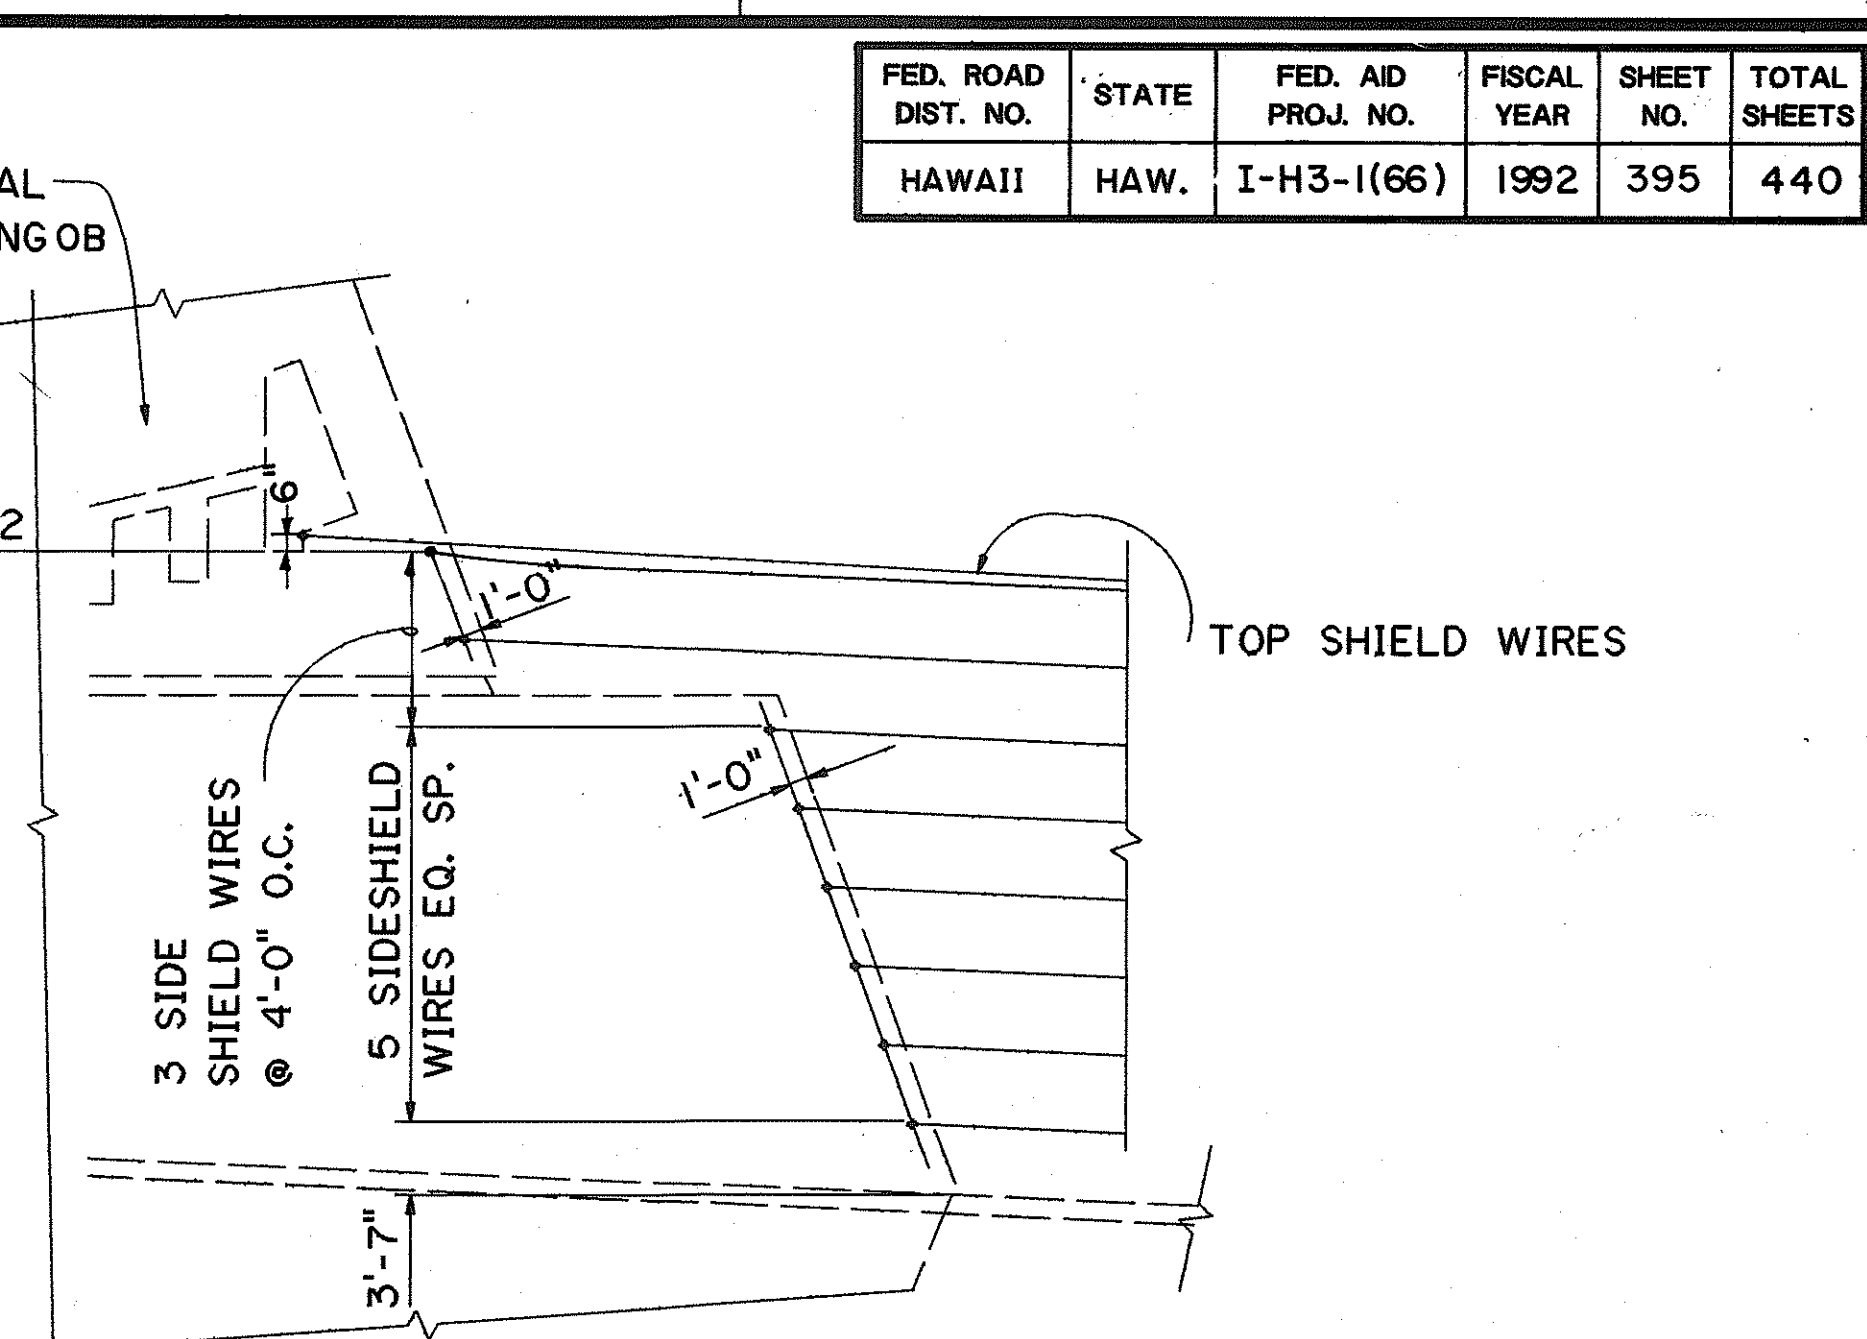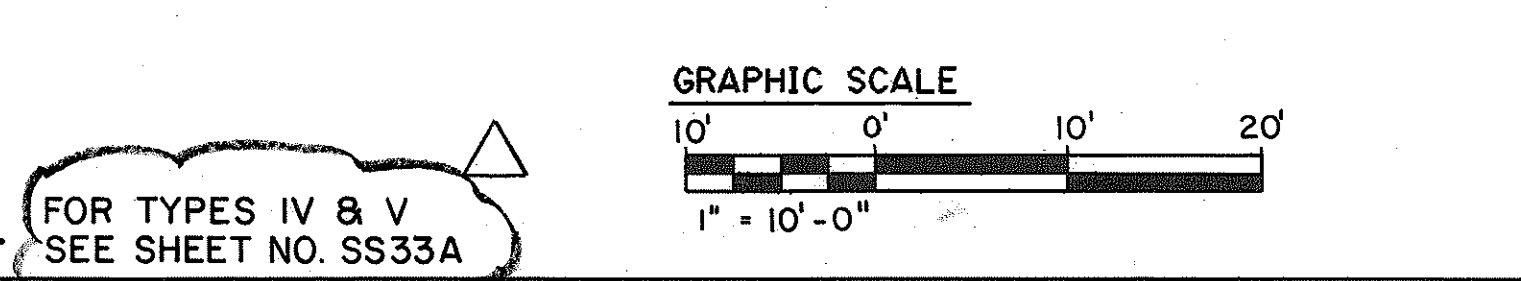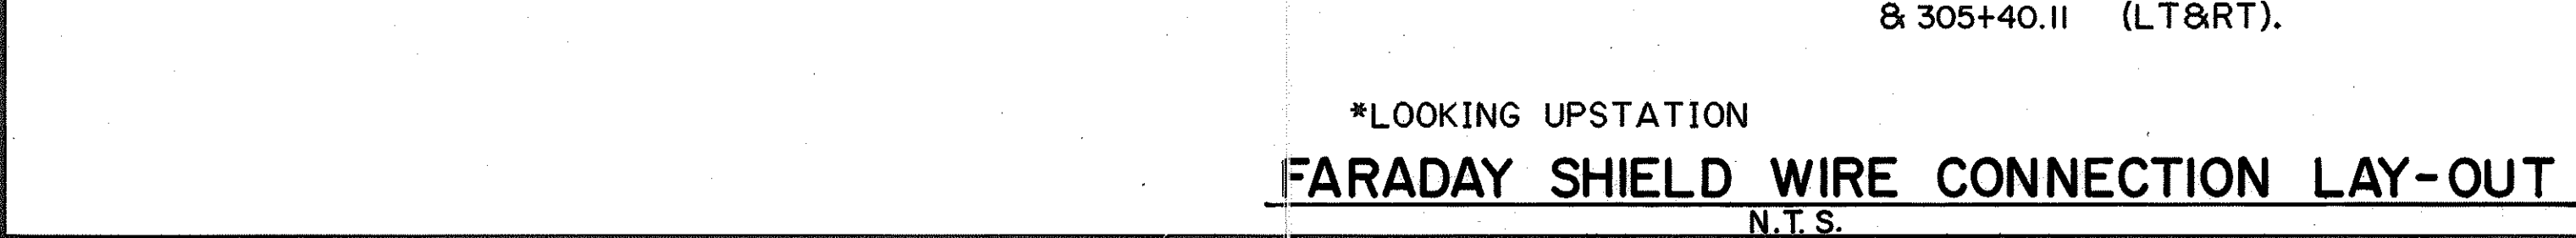

NOTE: SEE NOTES 1 THROUGH 4 ON SHEET NO. SS32.

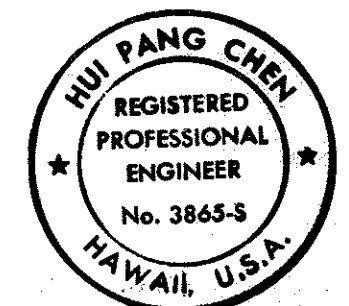


THIS WORK WAS PREPARED BY ME OR UNDER MY SUPERVISION

Hui Pang Chen

DATE	REVISION
7-14-93	REVISED FARADAY SHIELD WIRE DEAD-END CONNECTION TO CONCRETE & TYPE II END CONN. FOR POST & STRUT PER DCN 66-008


STATE OF HAWAII
DEPARTMENT OF TRANSPORTATION
HIGHWAYS DIVISION
MISCELLANEOUS DETAILS-5
SUPPORT STRUCTURES
INTERSTATE ROUTE H-3
F.A.I. PROJ. NO. I-H3-1(66)
SCALE: AS SHOWN DATE: APR. 1992
SHEET NO. SS33 OF 36 SHEETS

FED. ROAD DIST. NO.	STATE	FED. AID PROJ. NO.	FISCAL YEAR	SHEET NO.	TOTAL SHEETS
HAWAII	HAW.	I-H3-1(66)	1992	395 S-1	440

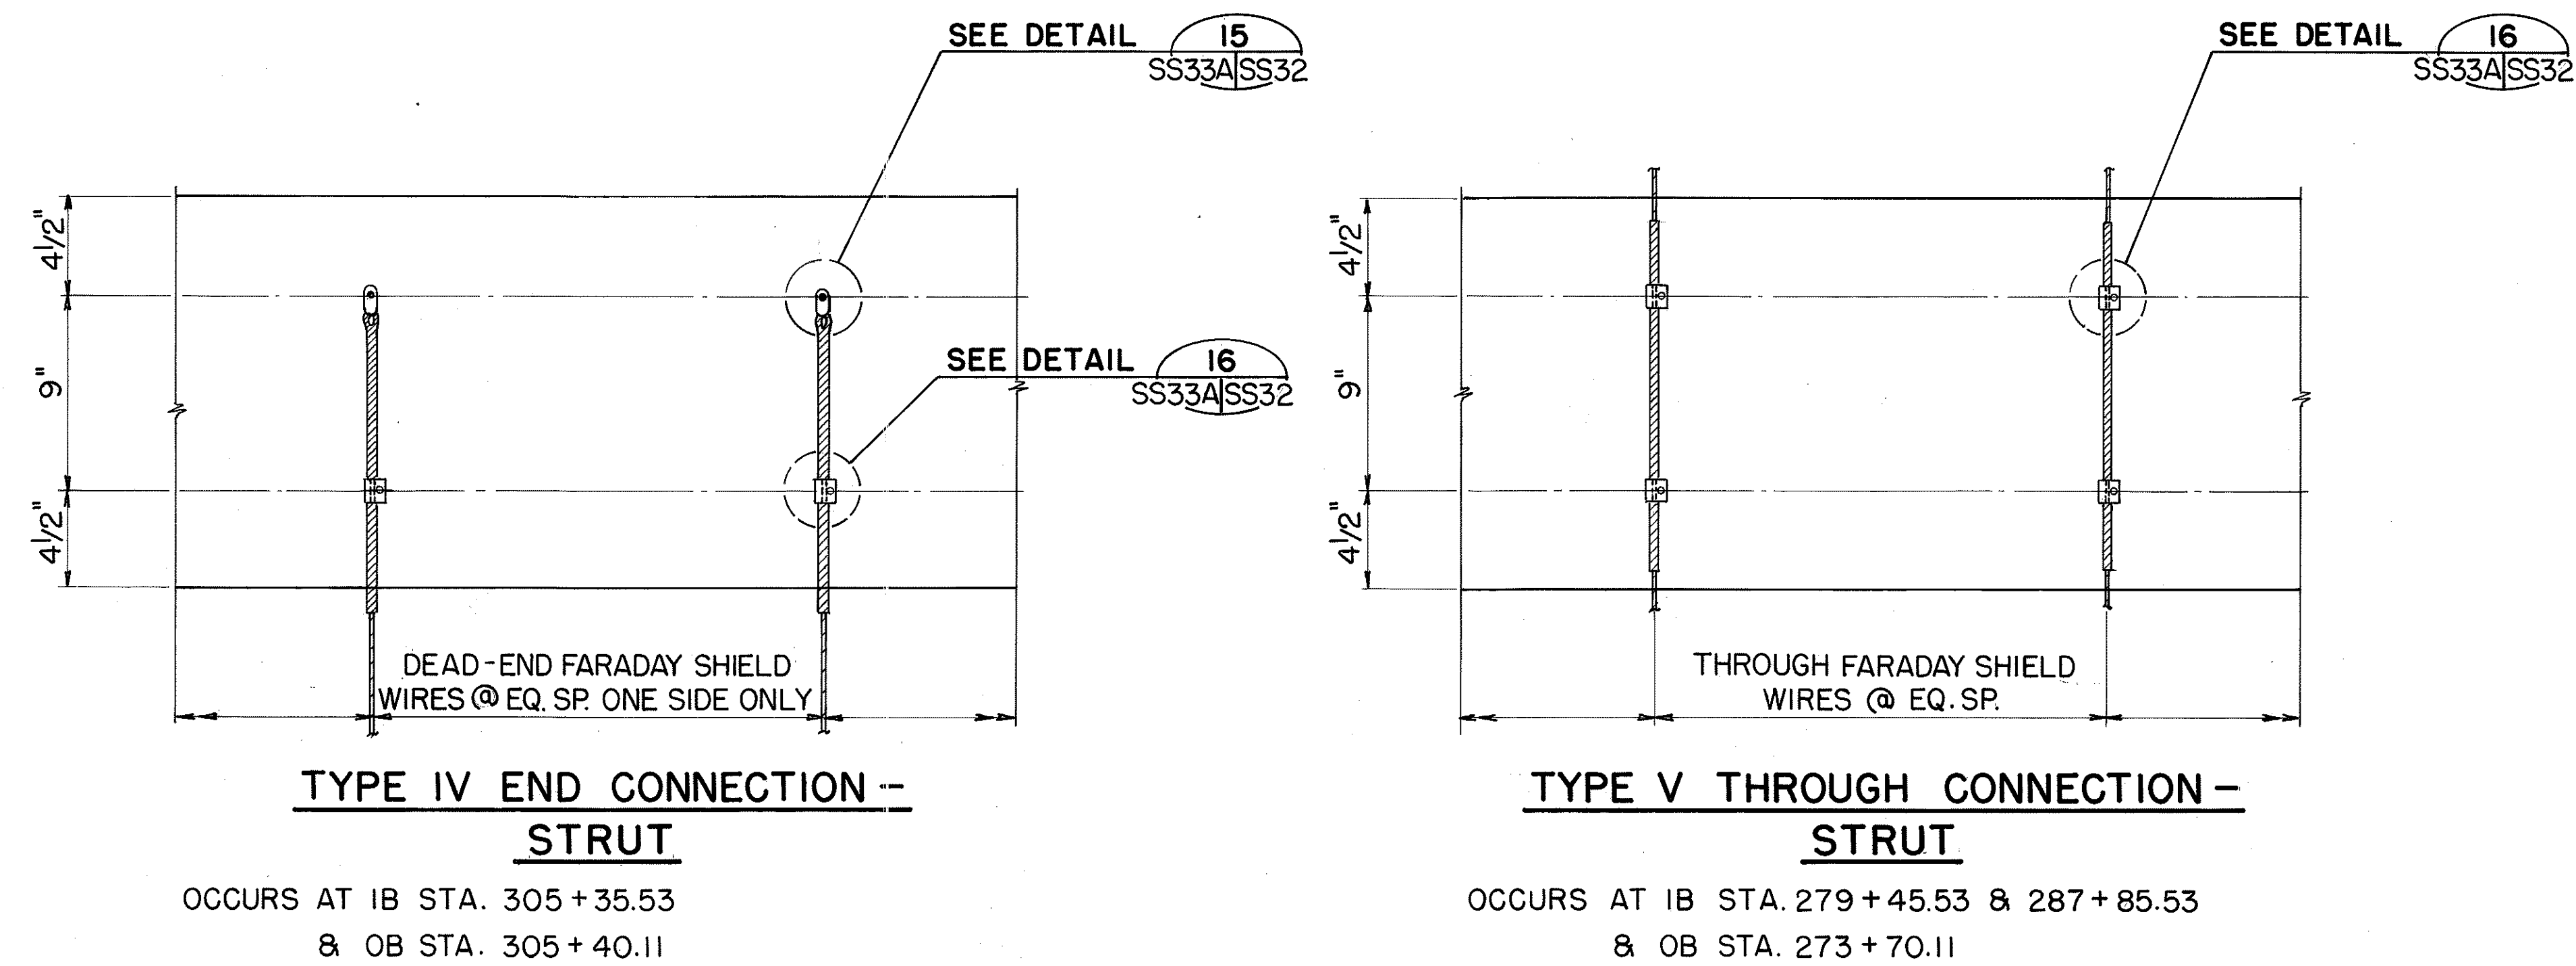

FARADAY SHIELD WIRE CONNECTION LAY-OUT
 N. T. S.

ORIGINAL PLAN	SURVEY PLOTTED BY	DATE
NOTE BOOK	DESIGNED BY	
No.	QUANTITIES BY	
	CHECKED BY	

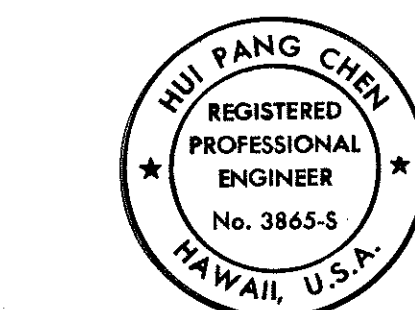


THIS WORK WAS PREPARED BY ME
 OR UNDER MY SUPERVISION


Hui Pang Chen

5-25-93	ADDED FARADAY SHIELD WIRE CONNECTION TYPE IV & V PER DCN 66-008
DATE	REVISION
STATE OF HAWAII DEPARTMENT OF TRANSPORTATION HIGHWAYS DIVISION MISCELLANEOUS DETAILS-5A SUPPORT STRUCTURES INTERSTATE ROUTE H-3 F.A.I. PROJ. NO. I-H3-1(66) SCALE: NONE DATE: MAY 1993 SHEET NO. SS33A OF 36 SHEETS	


FED. ROAD DIST. NO.	STATE	FED. AID PROJ. NO.	FISCAL YEAR	SHEET NO.	TOTAL SHEETS
HAWAII	HAW.	I-H3-(166)	1992	396	440

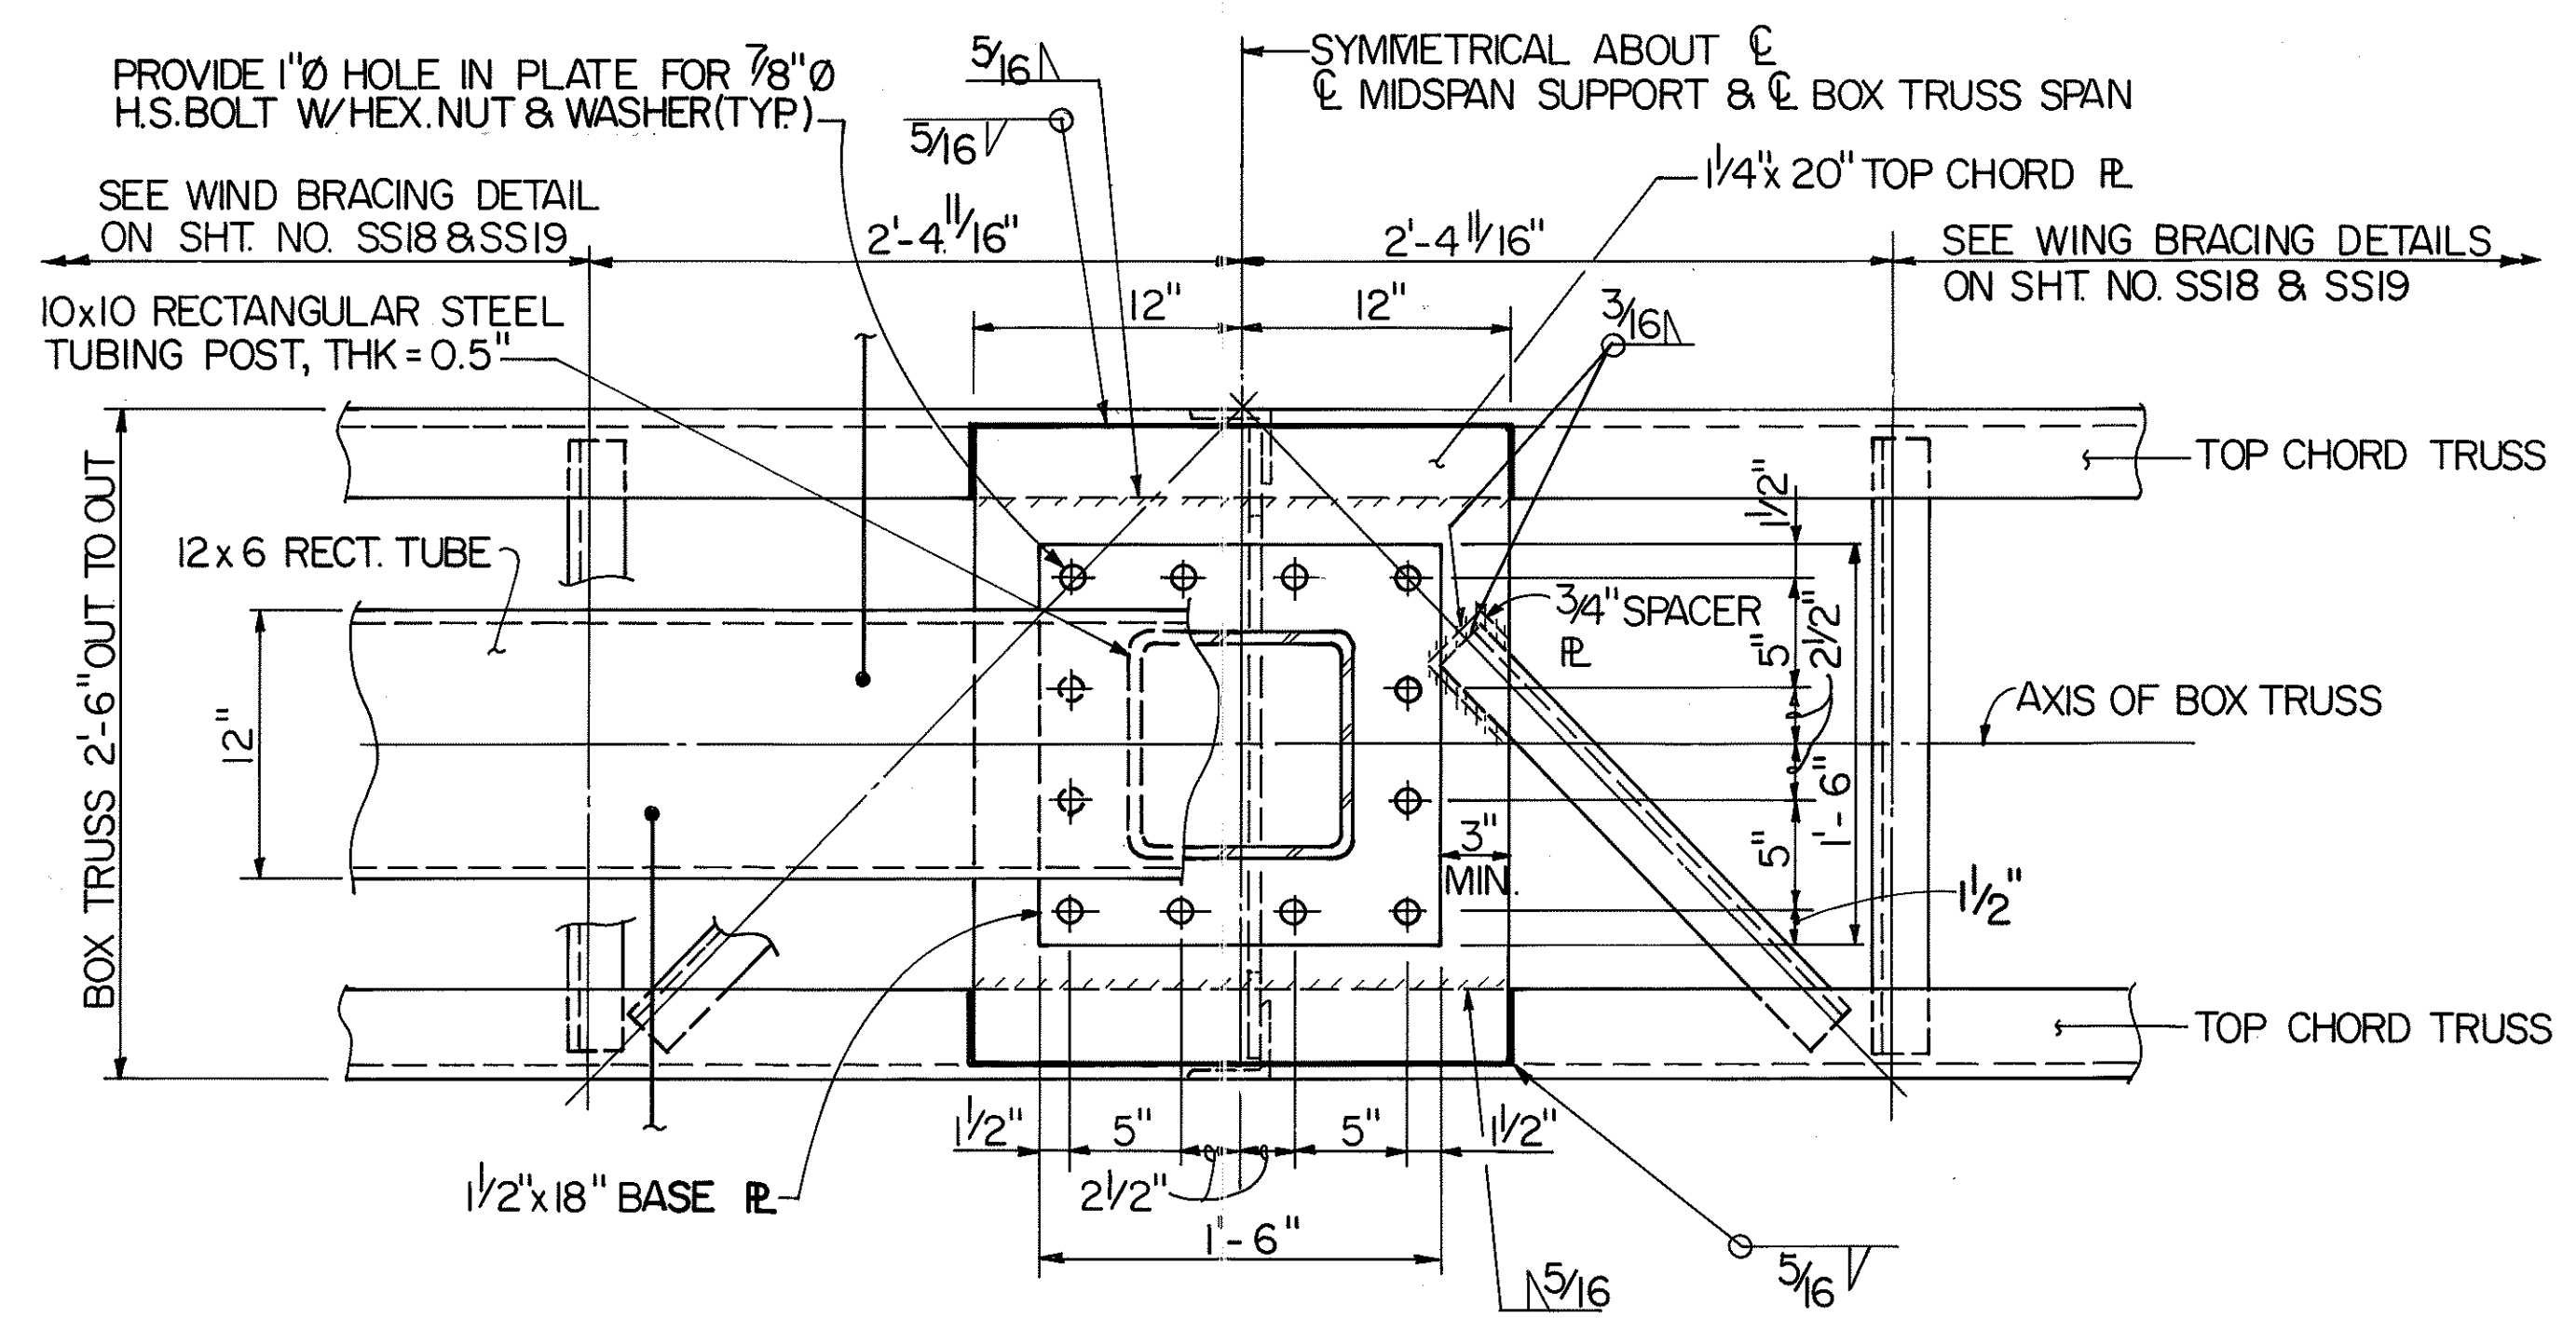


VIEW B (MIDSPAN SUPPORT)
SCALE: 1/2" = 1'-0" SS34 SS34 STA. 262 + 41.99 O.B.

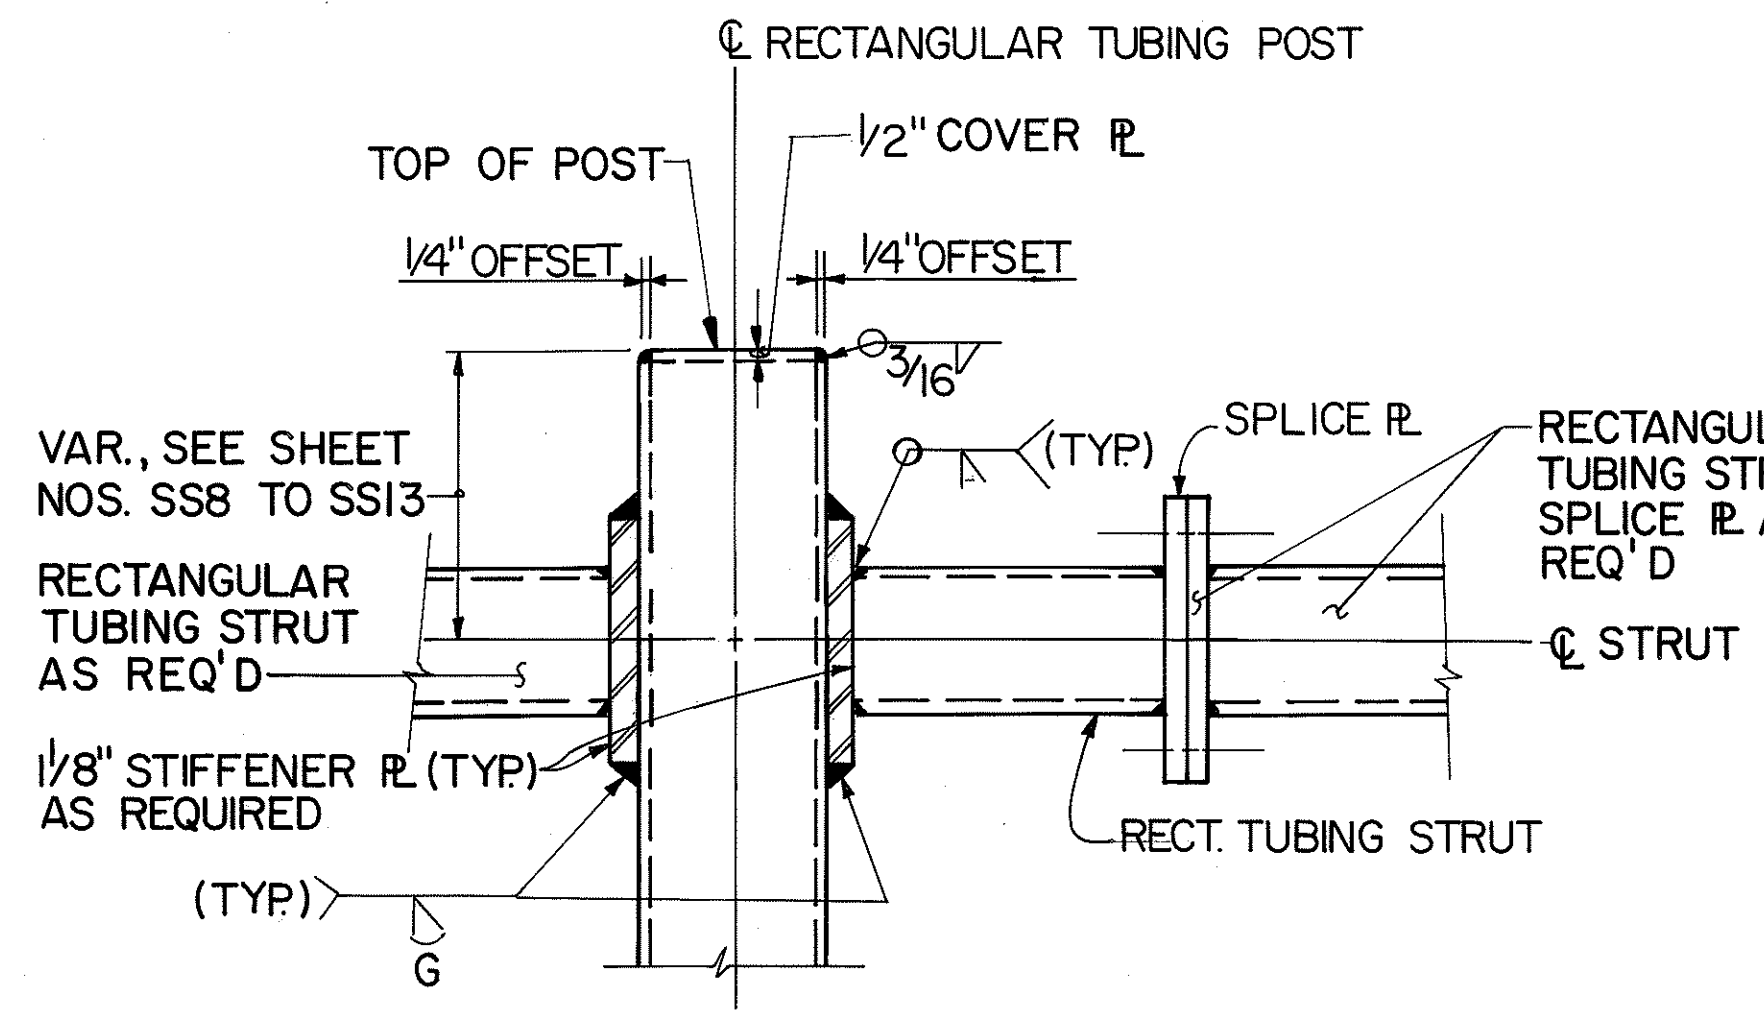


SECTION C
SCALE: 1/2" = 1'-0" SS30 SS34

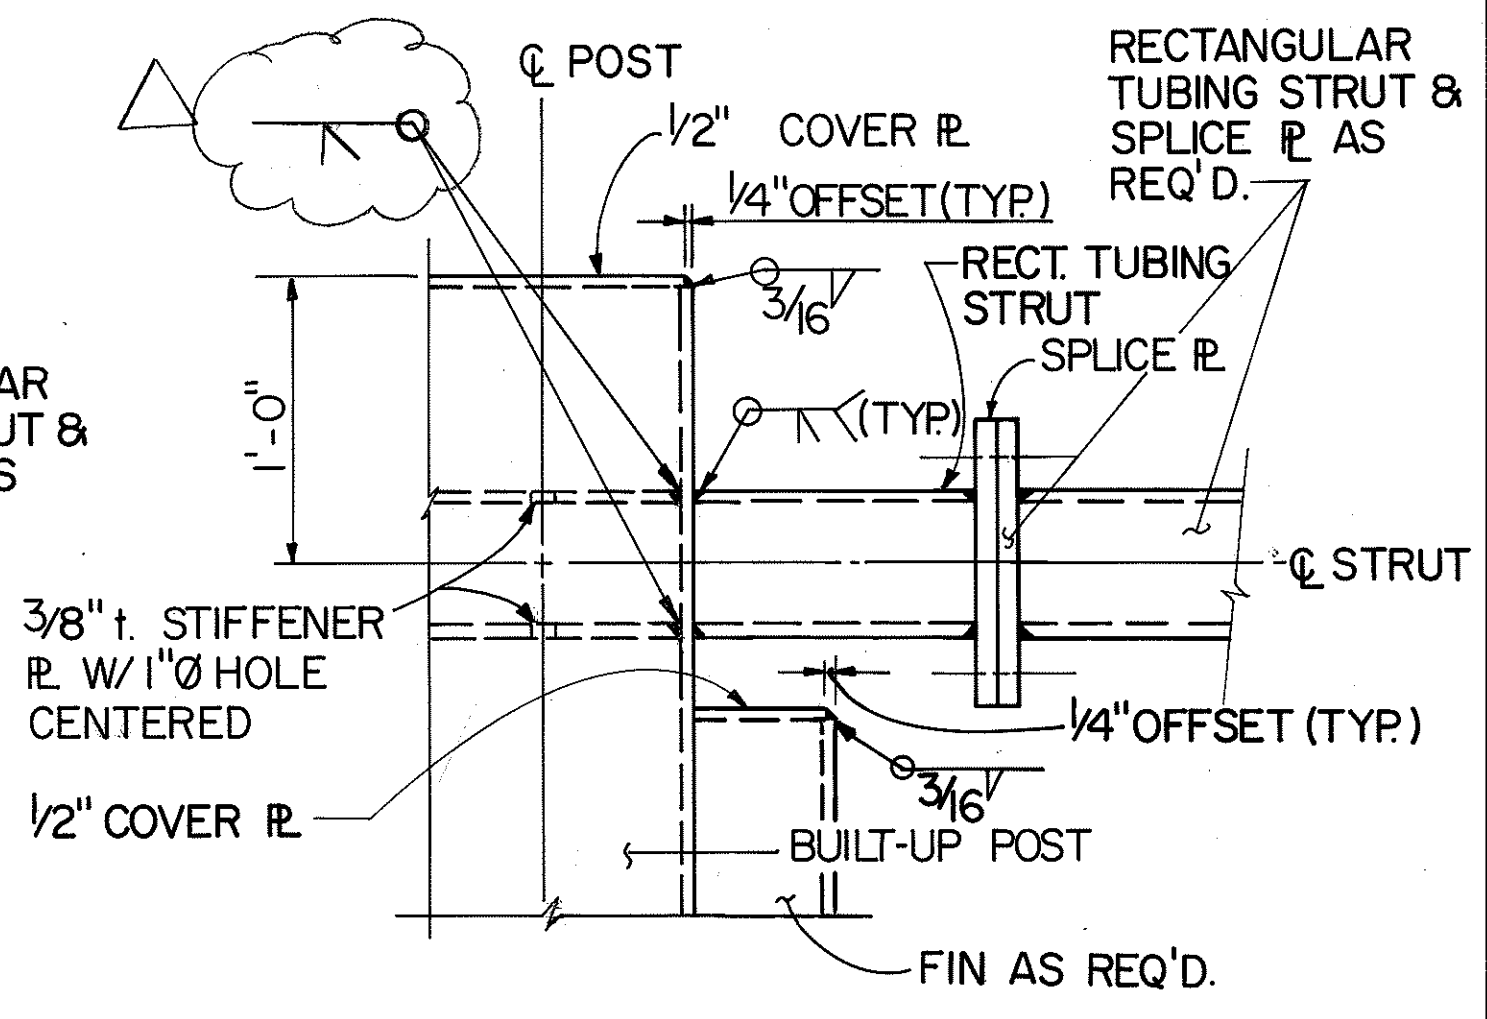


SECTION D
SCALE: 1/2" = 1'-0" SS30 SS34

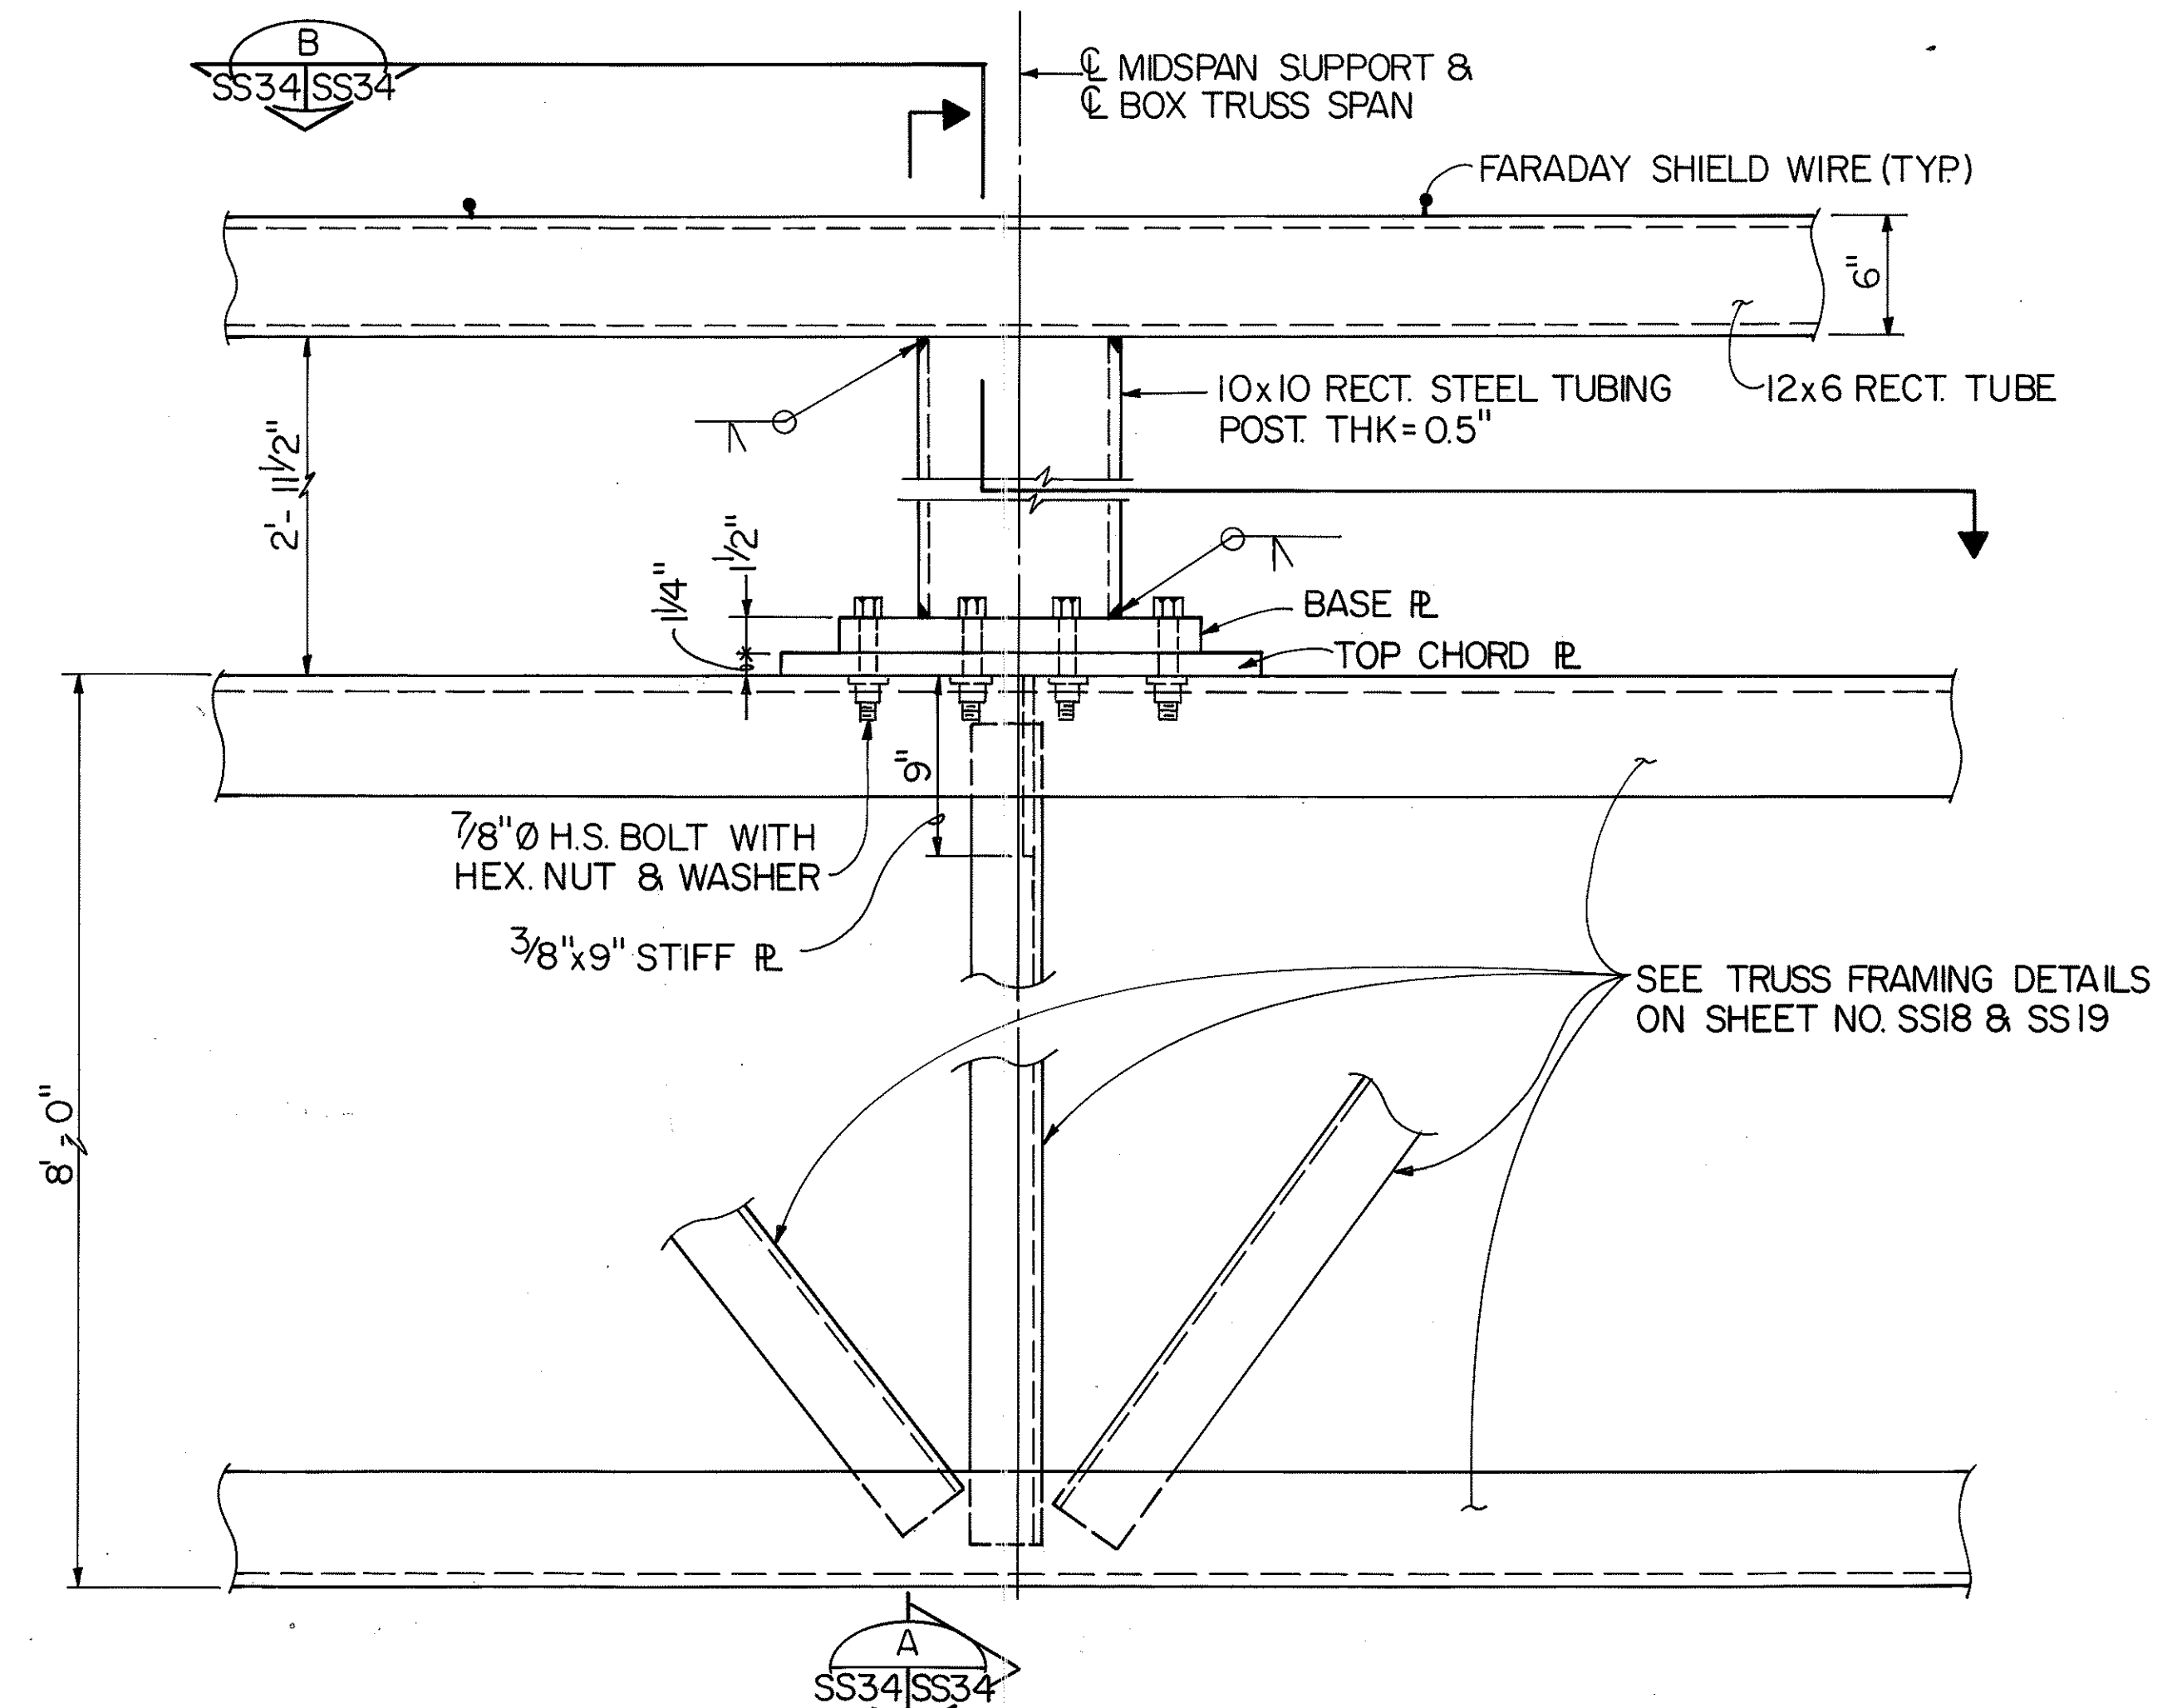

DETAIL 1 MIDSPAN SUPPORT ELEVATION
SCALE: 1/2" = 1'-0" SS11 SS34

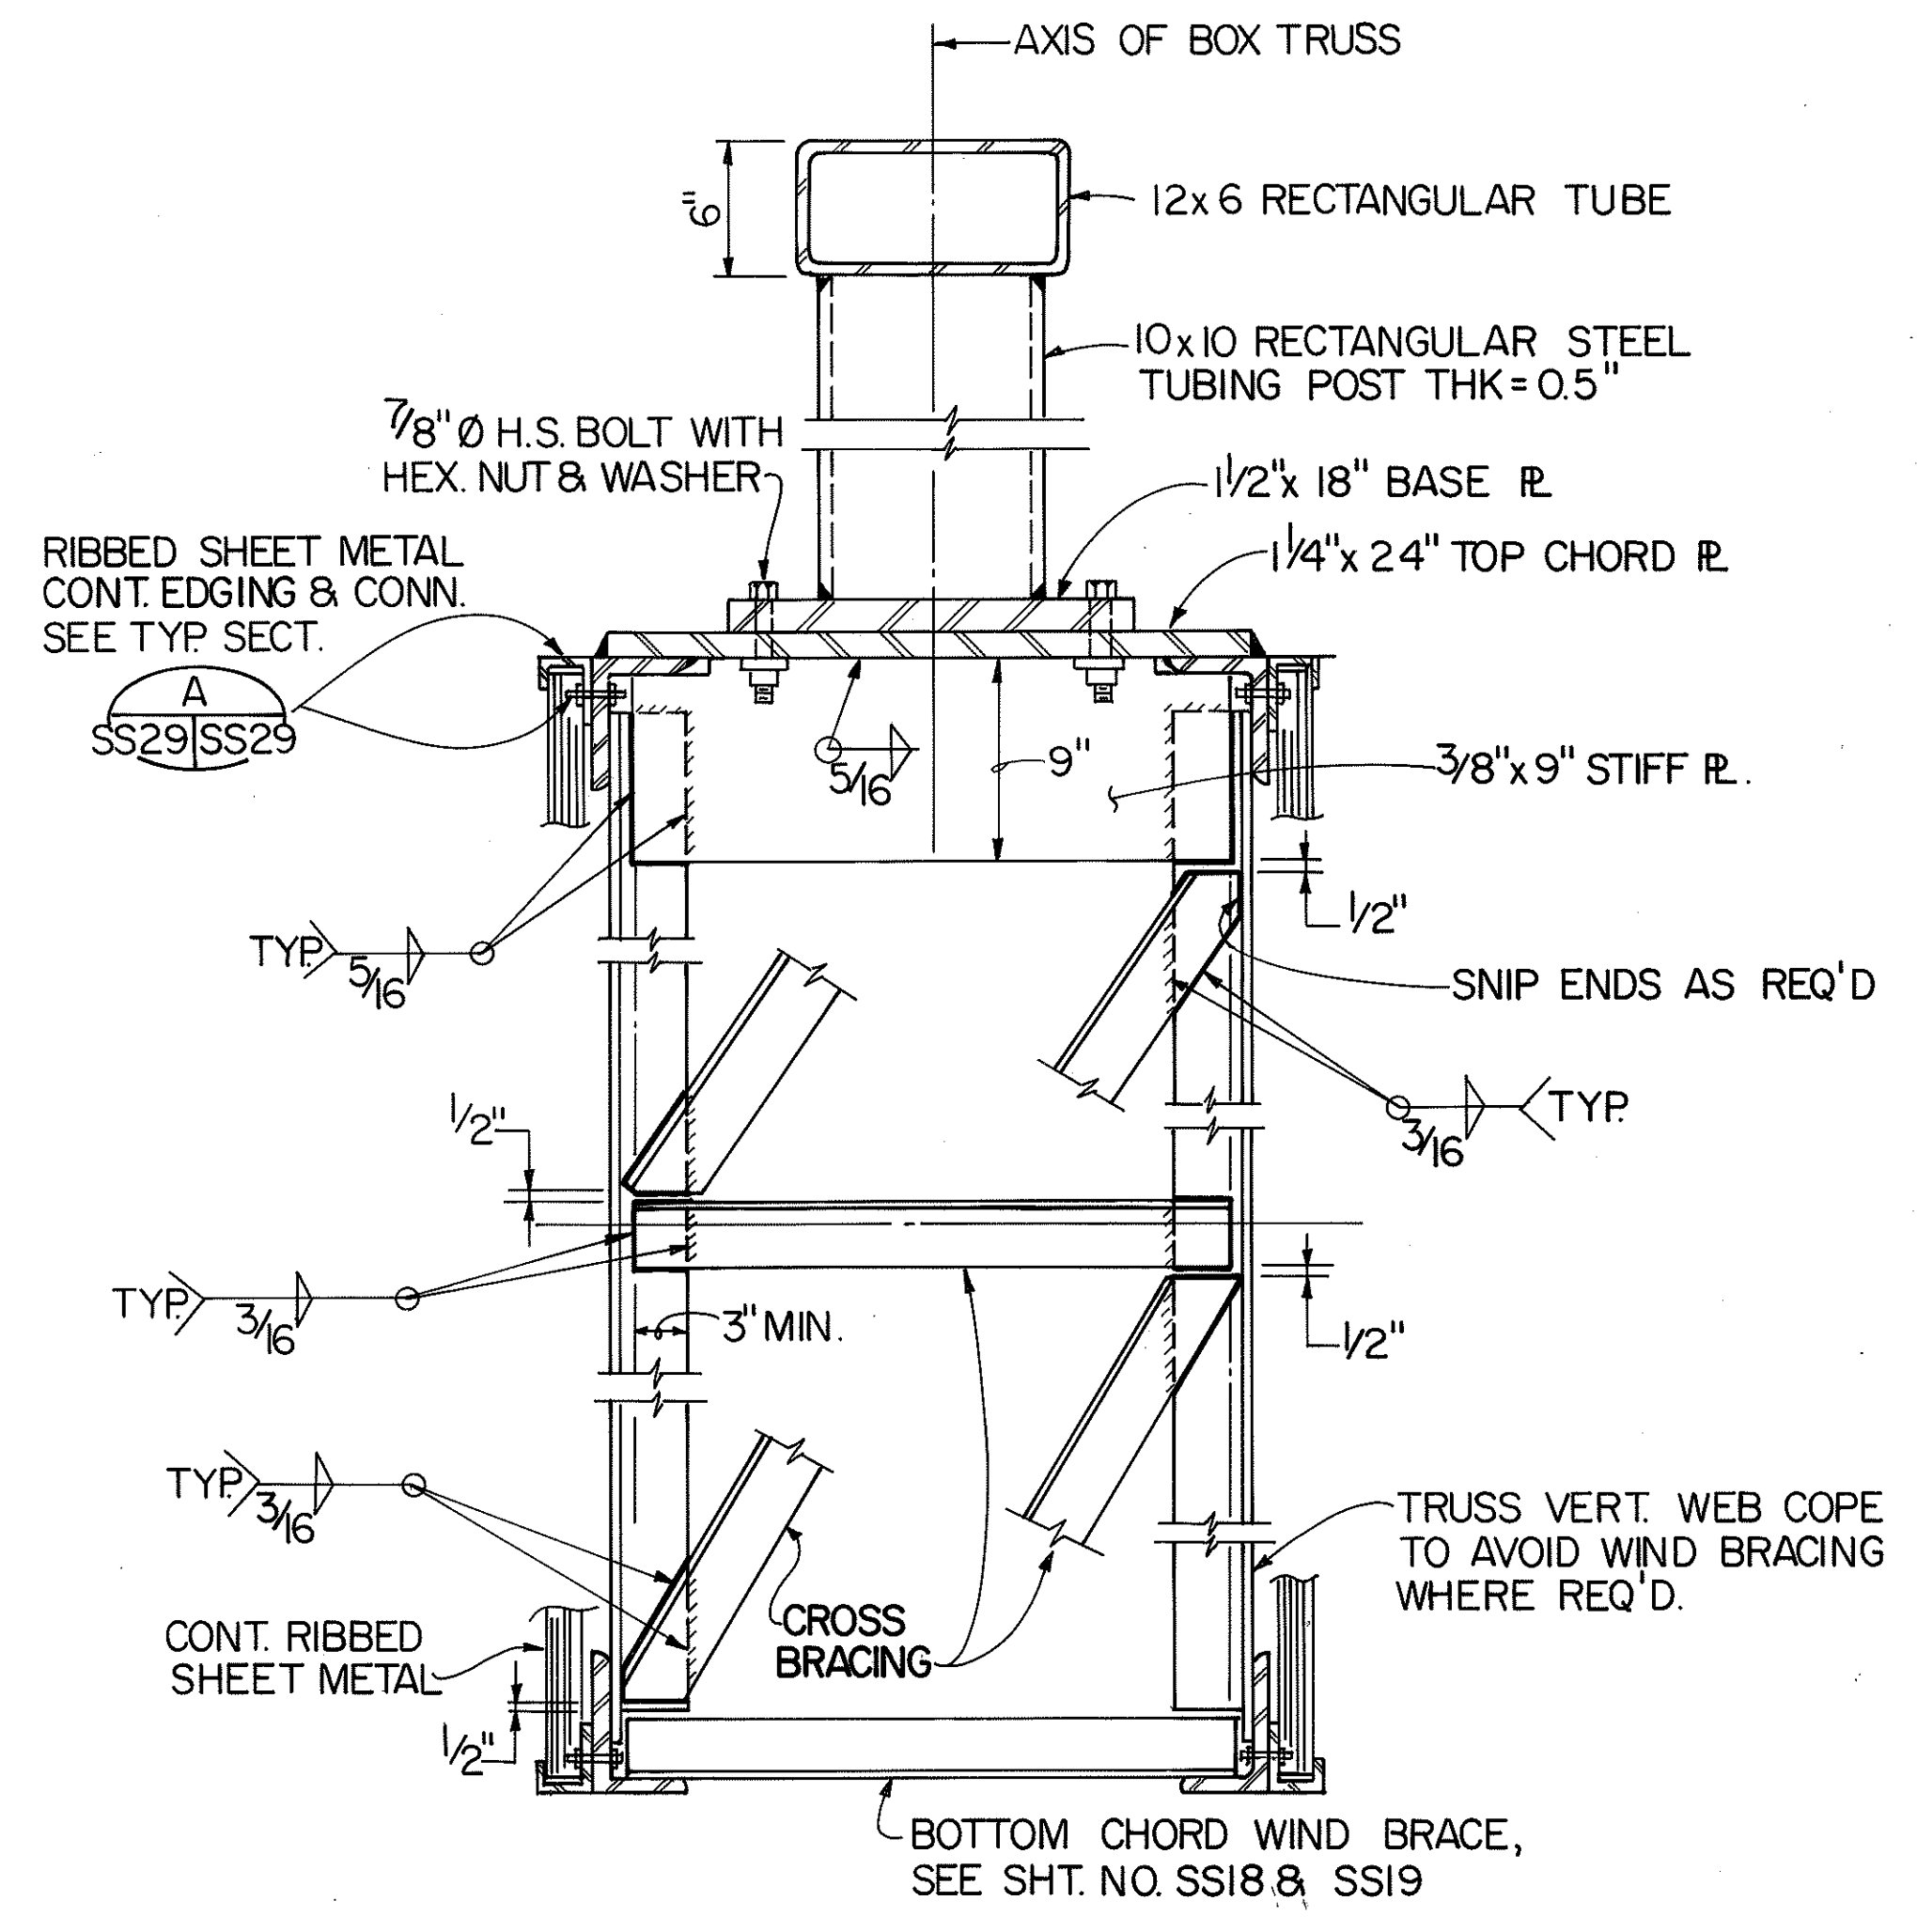

SECTION A
SCALE: 1/2" = 1'-0" SS34 SS34

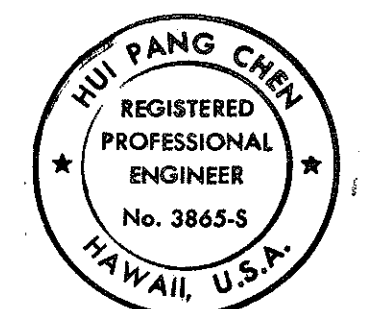


THIS WORK WAS PREPARED BY ME, OR UNDER MY SUPERVISION.
Hui Pang Chen


2/24/94	CLARIFY WELD PER DCN 66-036
DATE	REVISION
STATE OF HAWAII DEPARTMENT OF TRANSPORTATION HIGHWAYS DIVISION	
MISCELLANEOUS DETAILS-6	
SUPPORT STRUCTURES INTERSTATE ROUTE H-3 F.A.I. PROJ. NO. I-H3-1 (66)	
SCALE: AS SHOWN	DATE: APR. 1992
SHEET NO. SS34 OF 36 SHEETS	

FED. ROAD DIST. NO.	STATE	FED. AID PROJ. NO.	FISCAL YEAR	SHEET NO.	TOTAL SHEETS
HAWAII	HAW.	I-H3-1(66)	1992	397	440


- NOTES:
- See Sht. No. S1 (61) or (64) structural notes.
 - Structural steel shall be ASTM A36 hotdip galvanized.
 - See Sht. No. S2 (61) or (64) for anchor bolt details.
 - See Mechanical & Electrical plans for equipment foundation plan. The details of the equipment foundation shall be coordinated with the equipment supplier and submitted for acceptance by the engineer prior to construction.
 - The Nipple and End Cap shall be installed with Teflon tape to assure water tightness.

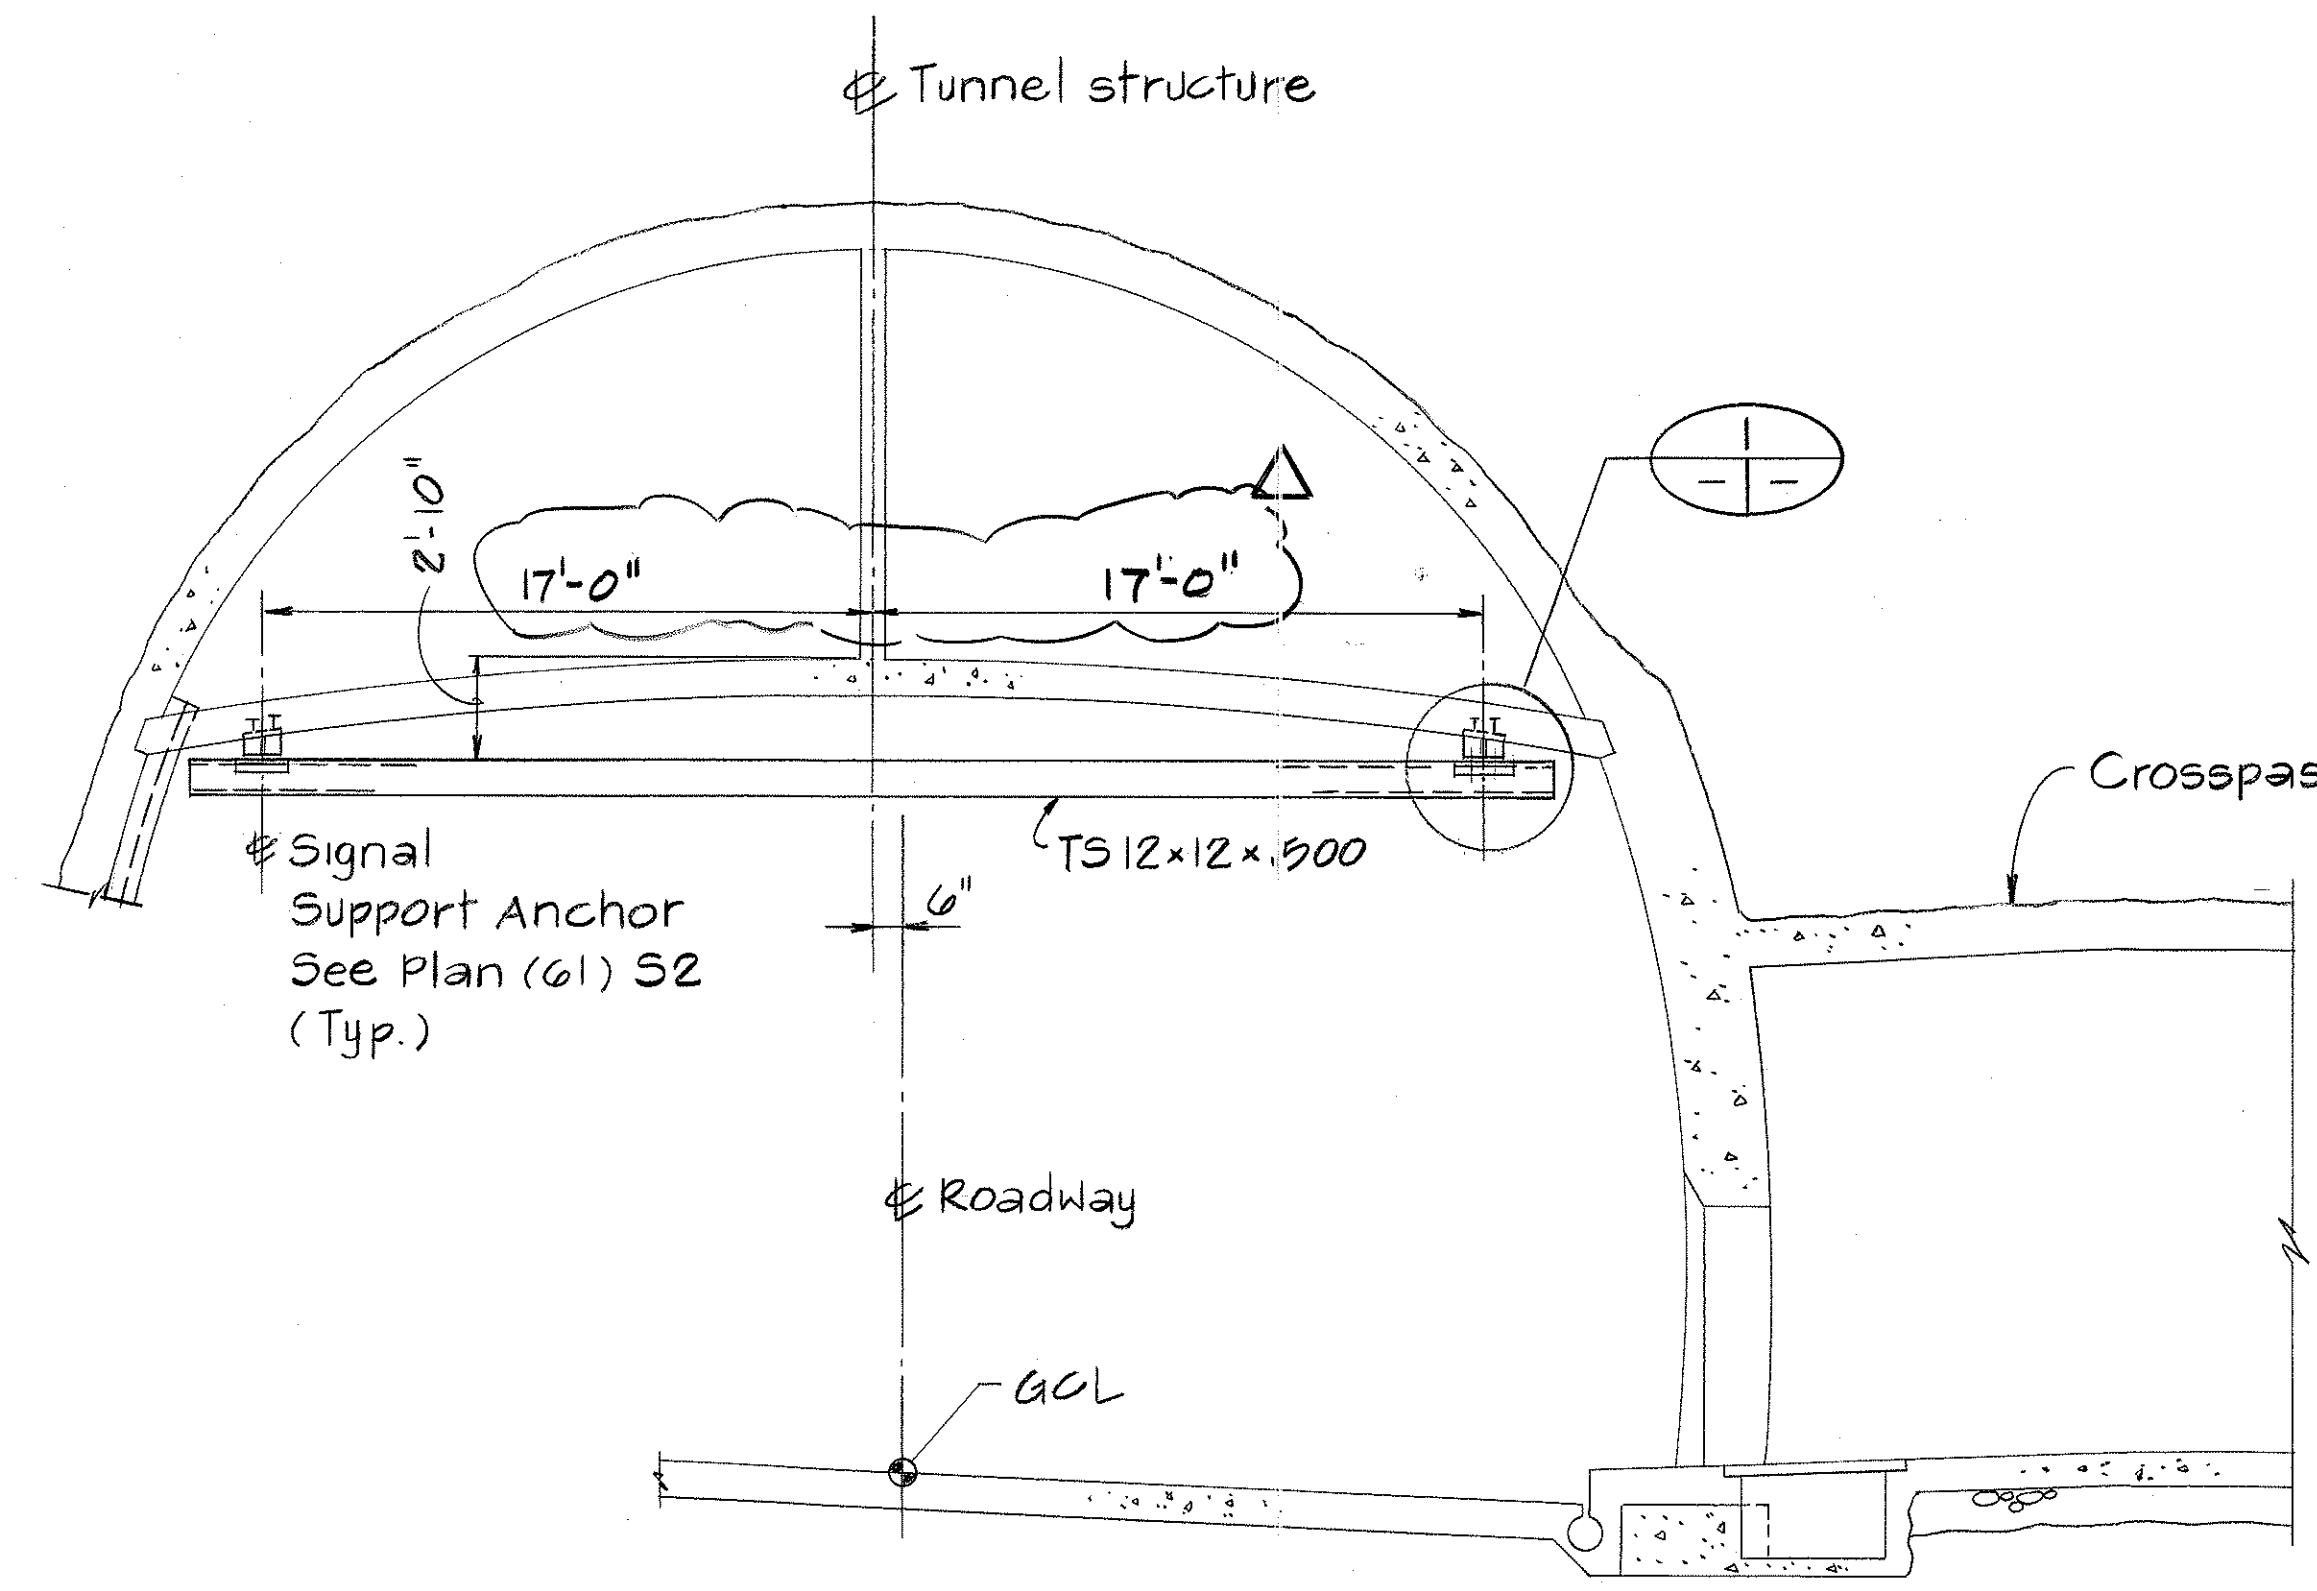

MONOTUBE SIGNAL SUPPORT
(1B SHOWN LOOKING EAST, OB OPPOSITE HAND, TYP.)
Scale: 3/16" = 1'-0"

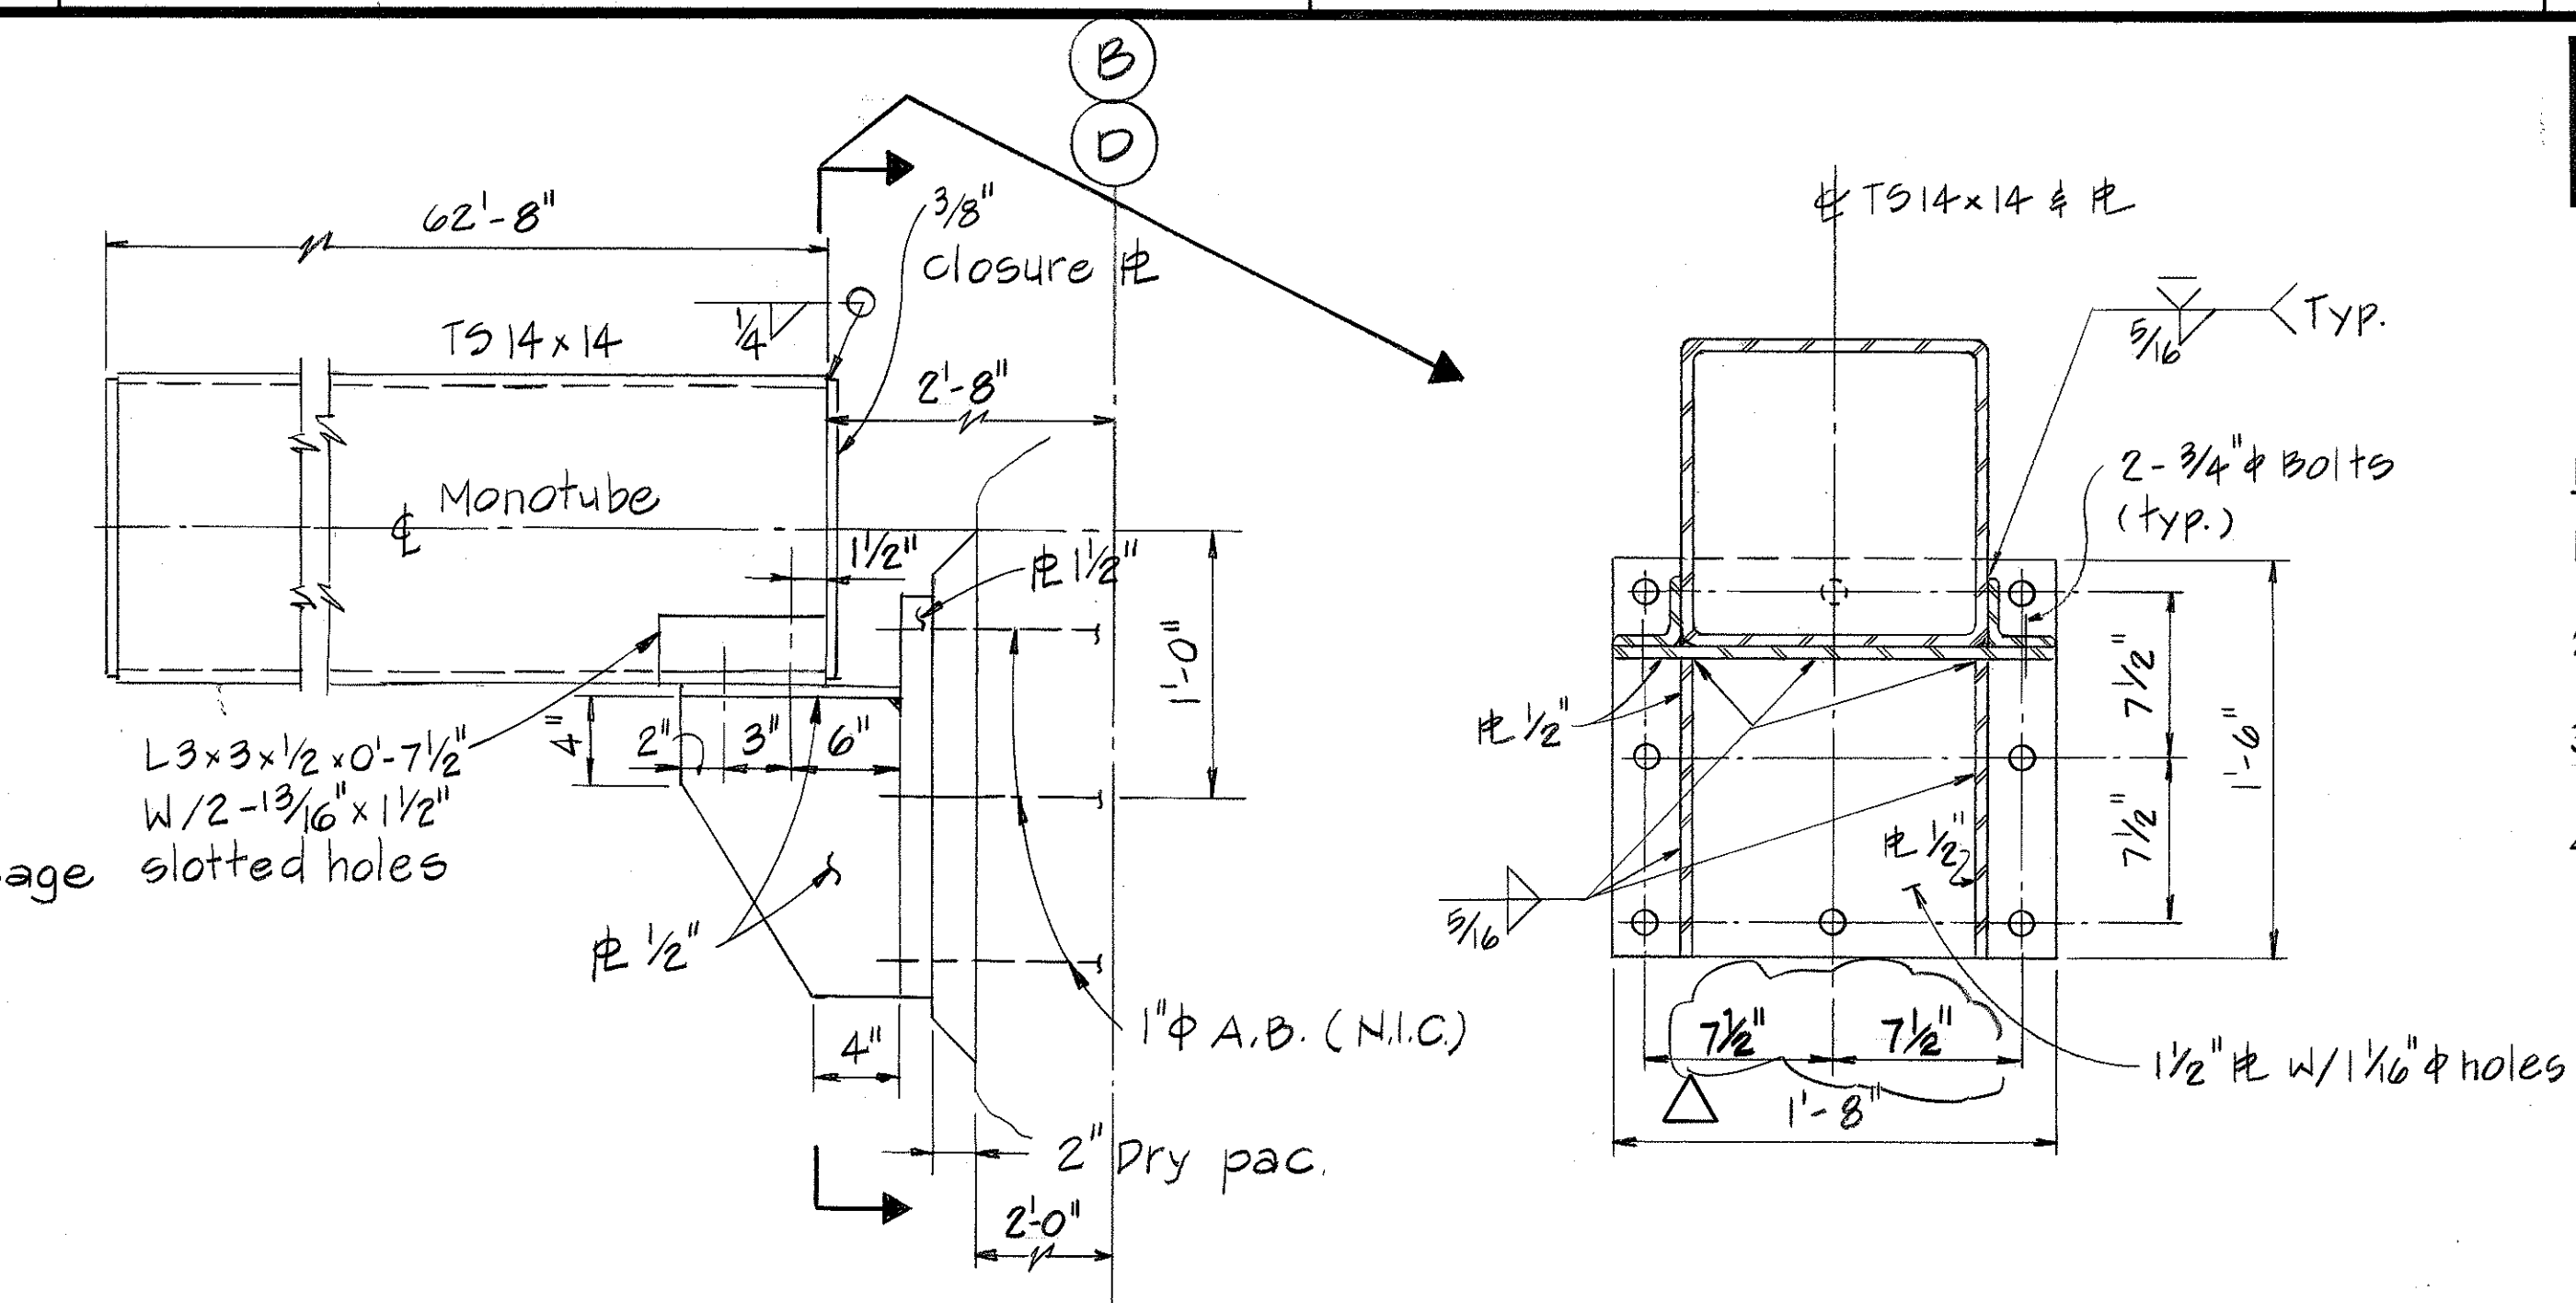


SIGNAL BRIDGE SUPPORT DETAIL
Scale: 1/2" = 1'-0"

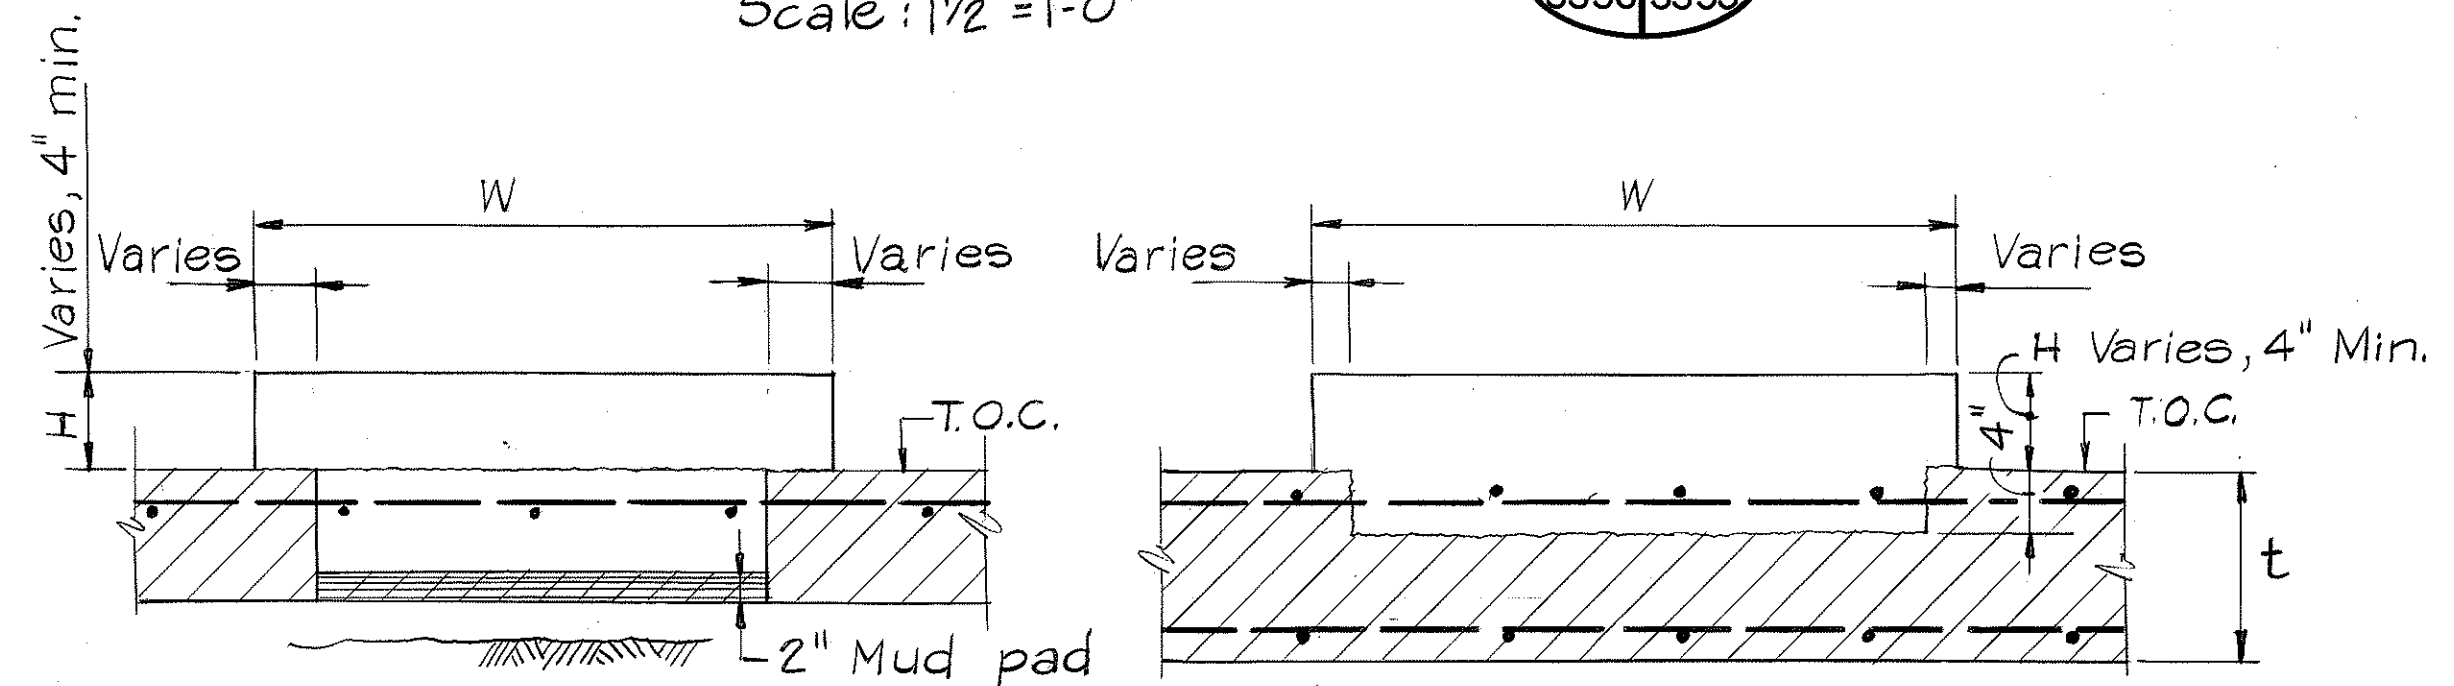


SLAB ON GRADE


FLOOR SLAB t ≥ 1'-0"

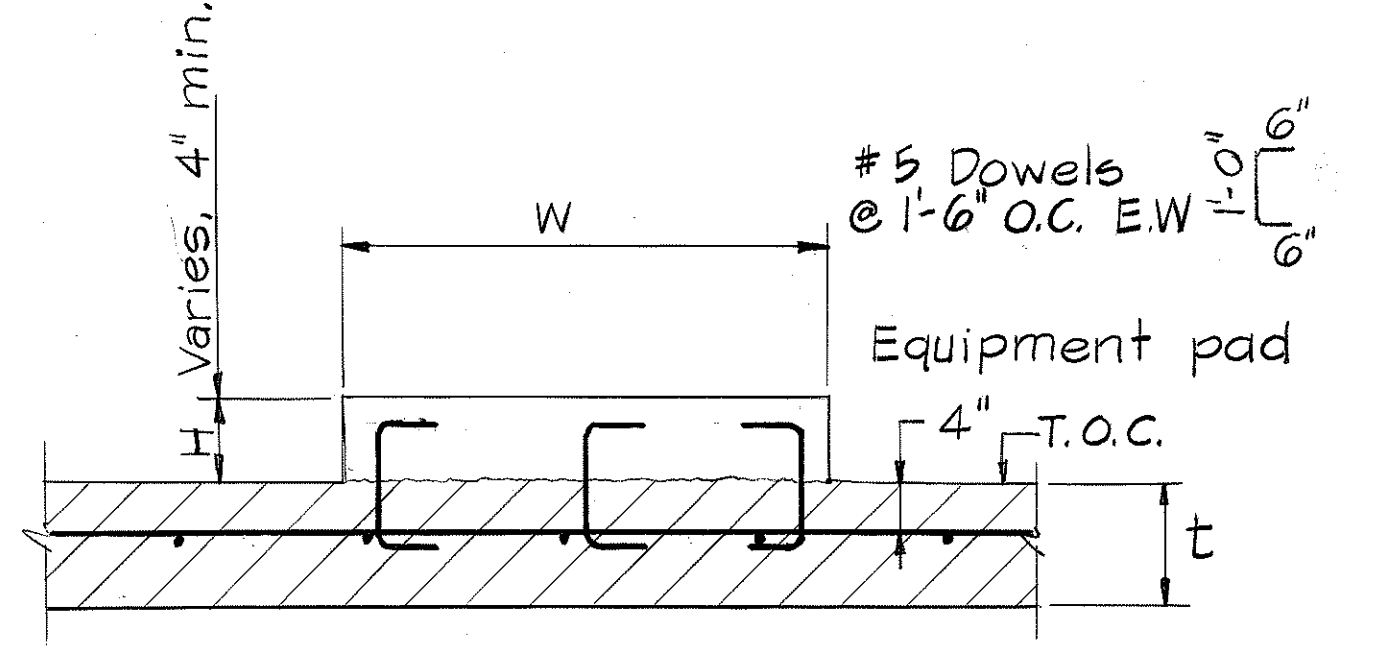

FLOOR SLAB t < 1'-0"

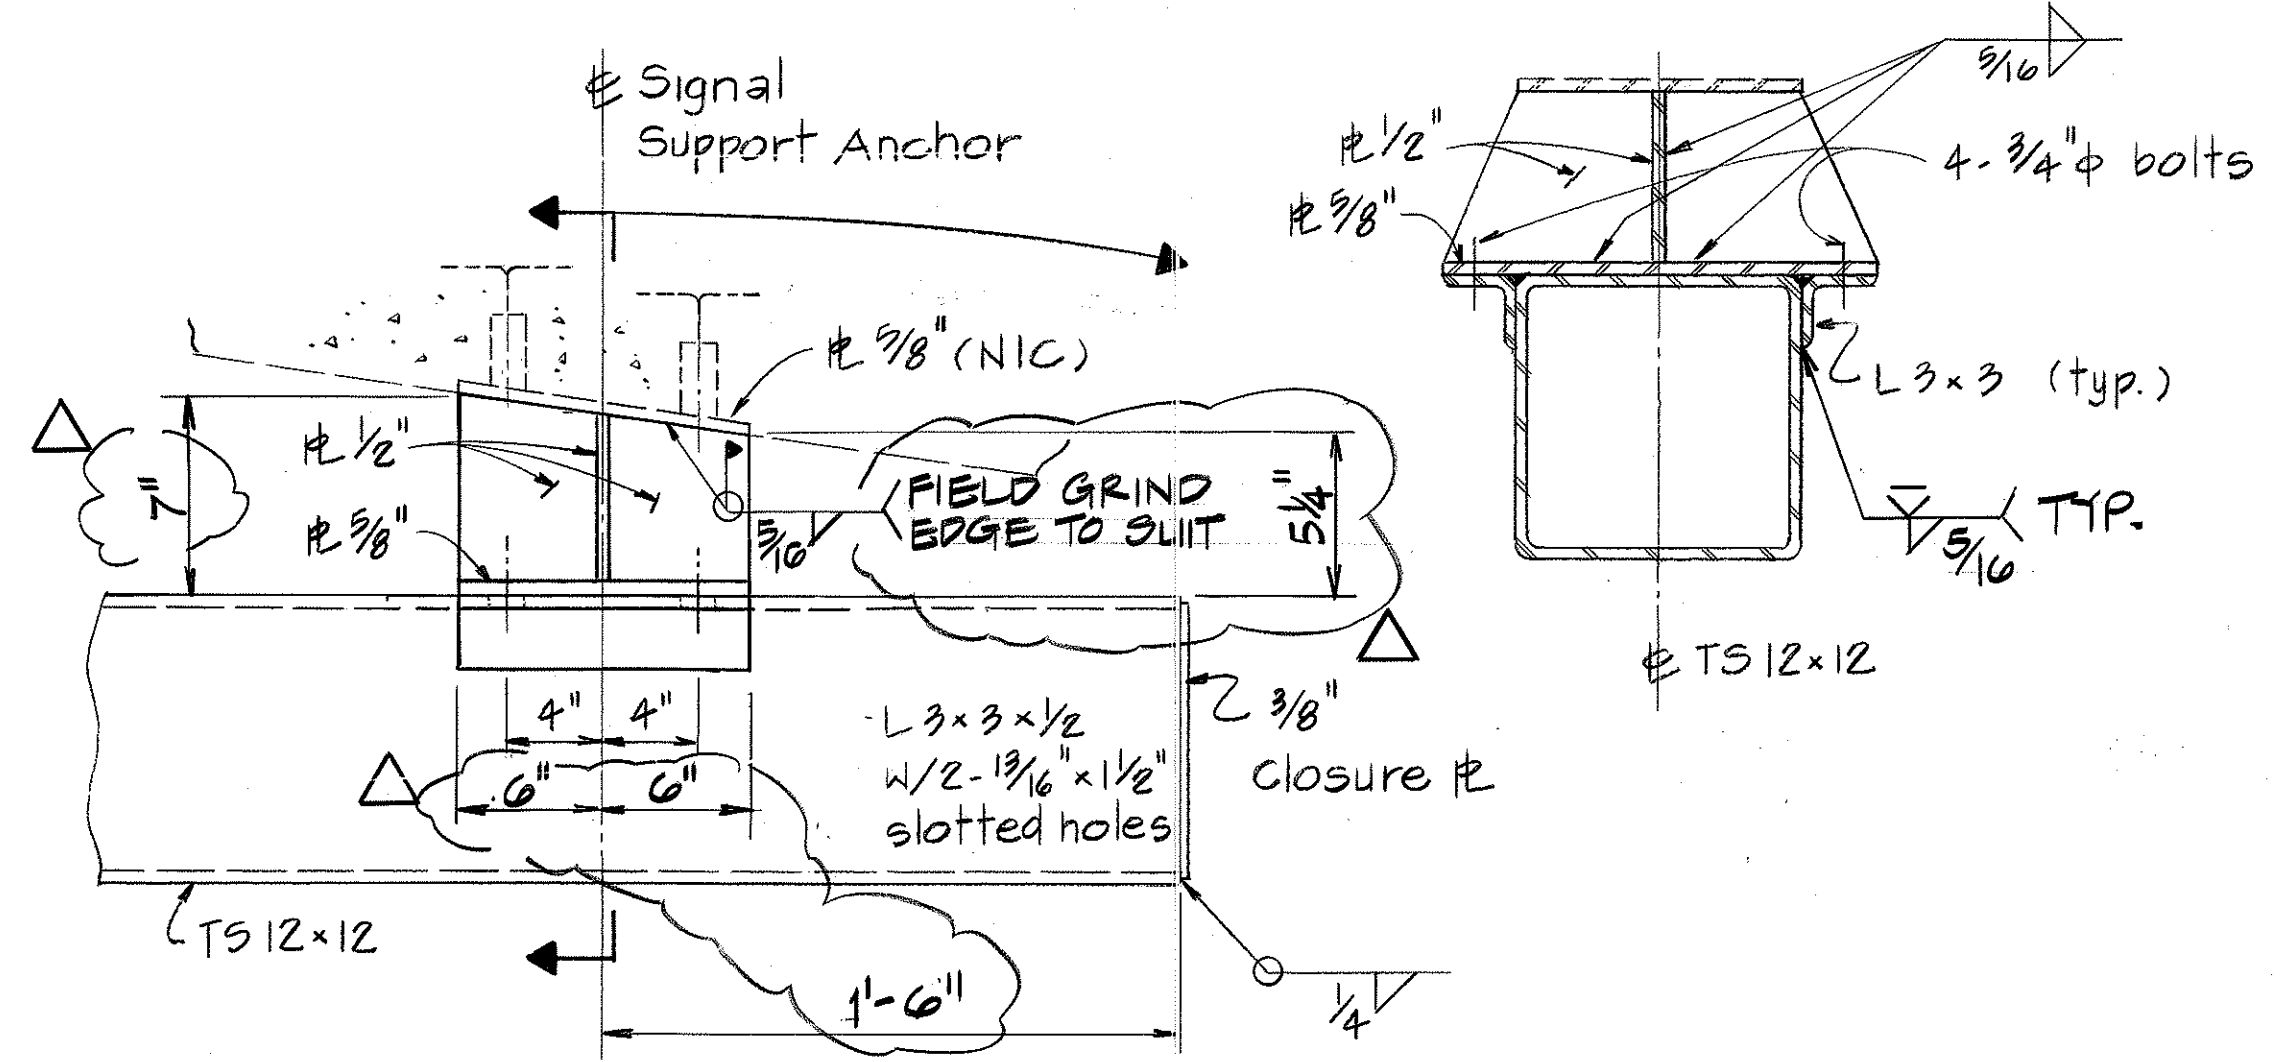


DETAIL
N.T.S.

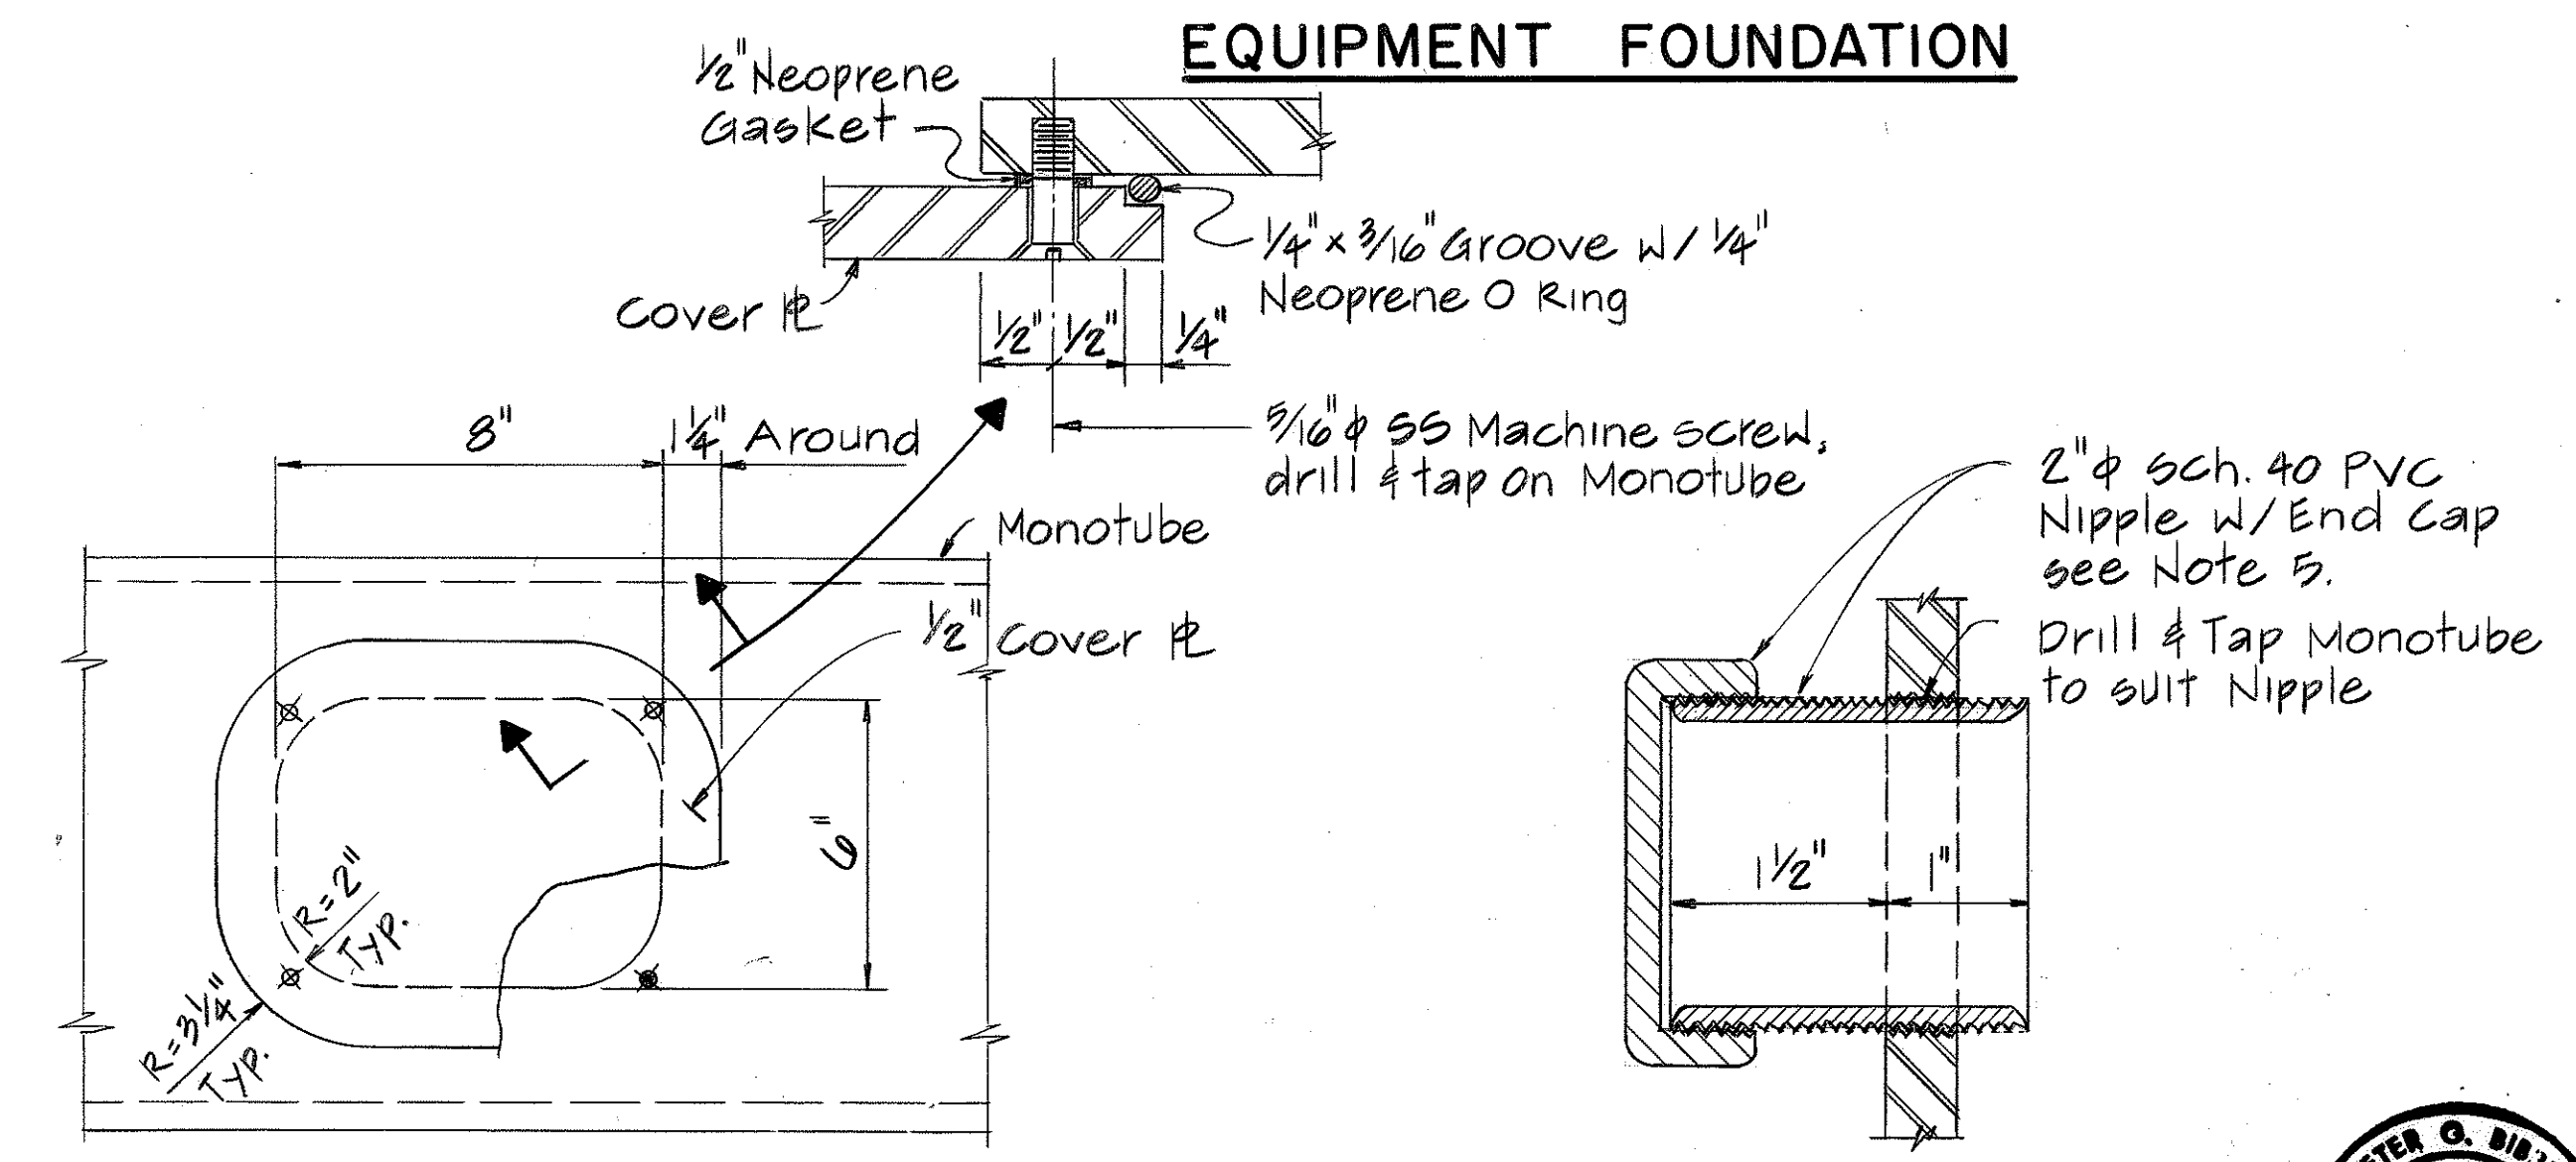

FRONT VIEW

DETAIL
N.T.S.

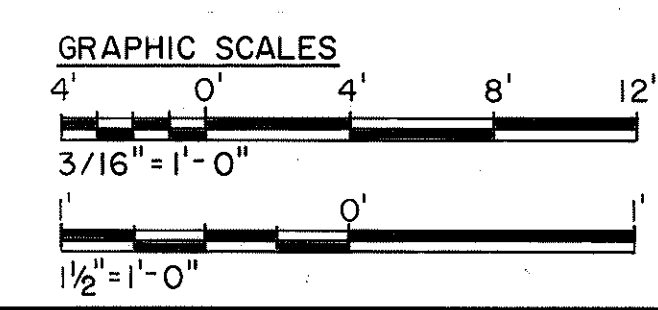


THIS WORK WAS PREPARED BY ME OR UNDER MY SUPERVISION


DATE	3/22/93	REVISION	REVISED ANCHOR POINT LAYOUT DIMENSIONS & DETAILS PER DCN NO. 66-002
STATE OF HAWAII DEPARTMENT OF TRANSPORTATION HIGHWAYS DIVISION			
MISCELLANEOUS DETAILS - 7			
SUPPORT STRUCTURES INTERSTATE ROUTE H-3 F.A.I. PROJ. NO. I-H3-1 (66)			
SCALE: AS NOTED		DATE: APR 1992	
SHEET NO. SS35 OF 36 SHEETS			

FED. ROAD DIST. NO.	STATE	FED. AID PROJ. NO.	FISCAL YEAR	SHEET NO.	TOTAL SHEETS
HAWAII	HAW.	I-H3-1(66)	1992	398	440

5/8" PL. BY OTHERS (TYP.)
SUPPORT DETAIL
SEE DETAIL 1
SHEET NO. SS35

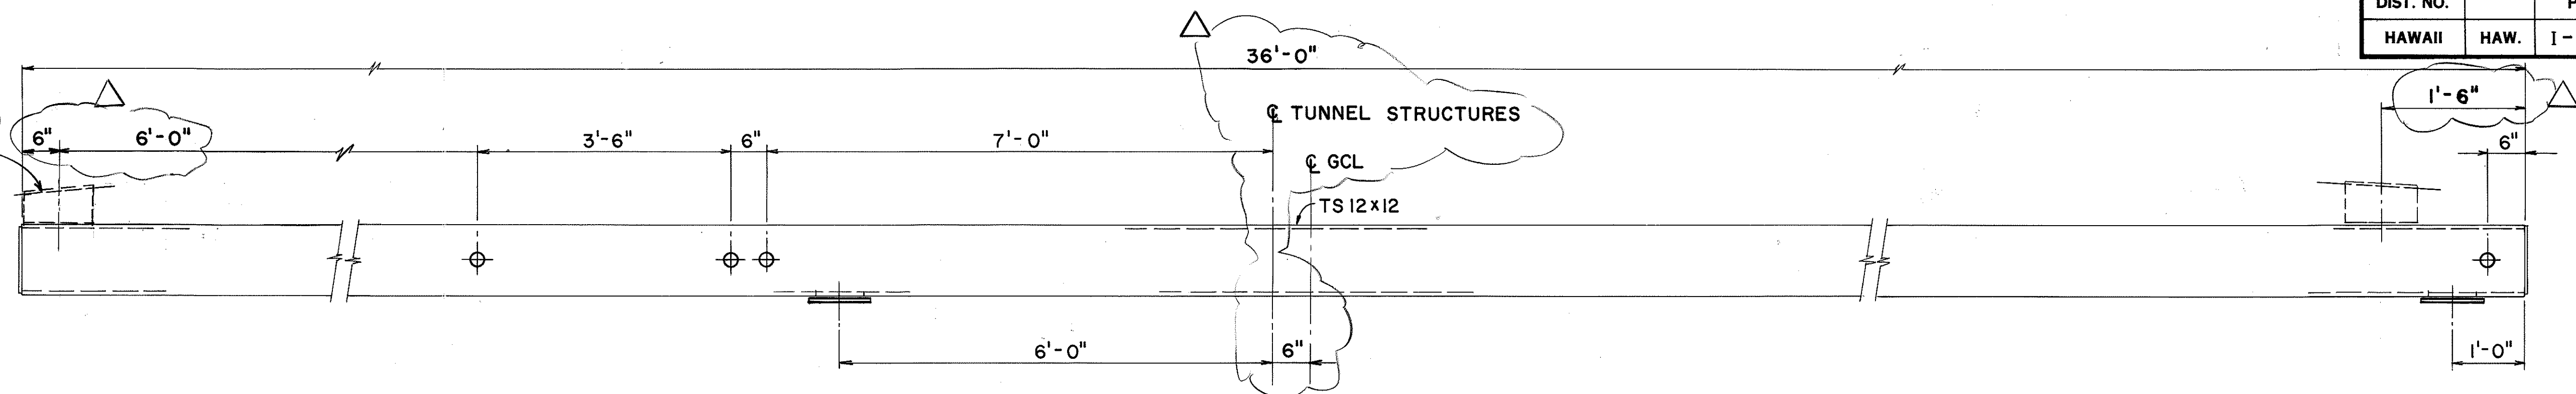


AT EVEN NUMBERED CROSSPASSAGE (10 REQ'D)

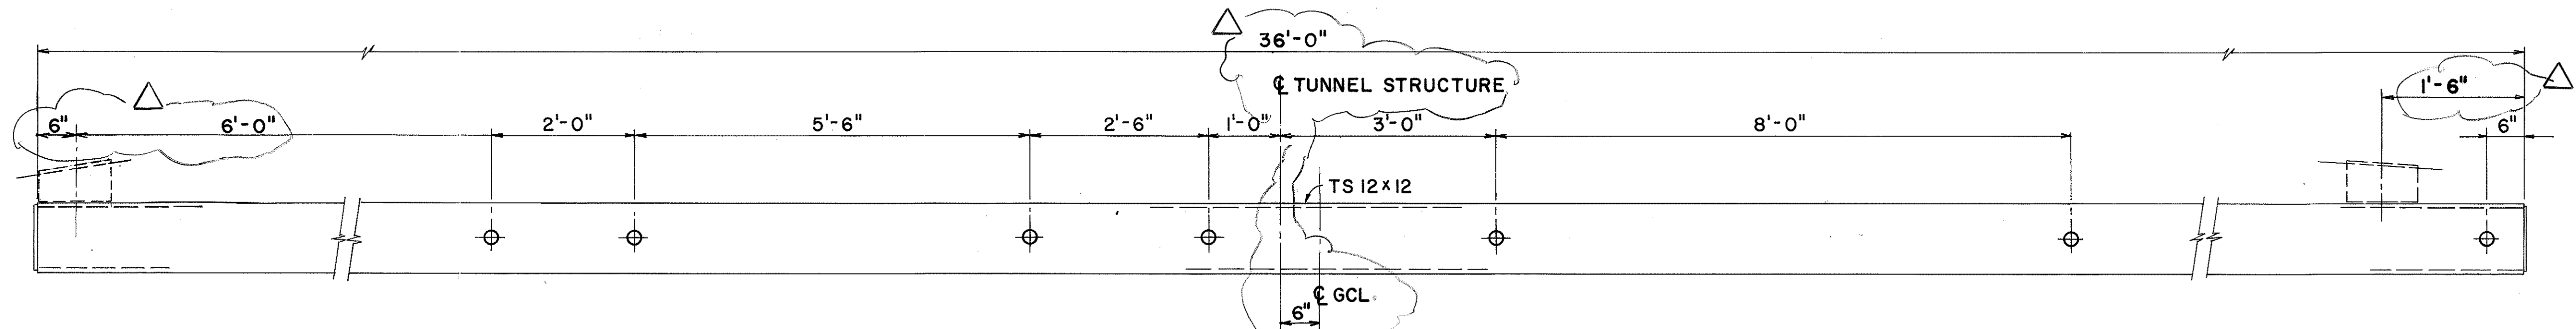

AT ODD NUMBERED CROSSPASSAGE (10 REQ'D)

MONOTUBE SIGNAL SUPPORT


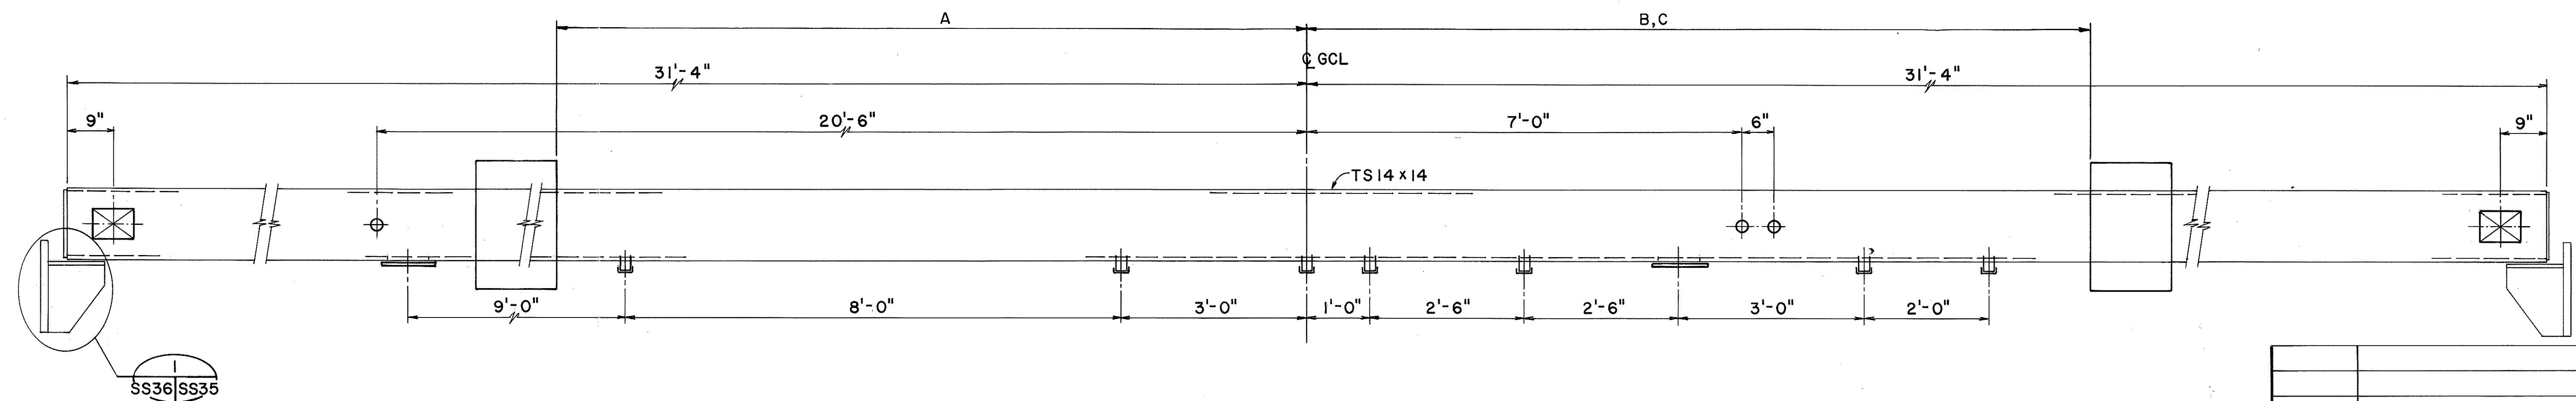


SIGNAL BRIDGE (4 REQ'D)

LEGEND

- 6"x8" HANDHOLE AT BOTH SIDES
- 6"x8" HANDHOLE AT BOTTOM SIDE
- 2" DIA. NIPPLE AT BOTH SIDES
- 2" DIA. NIPPLE AT BOTTOM SIDE
- FIXED MESSAGE SIGN

LOCATION	OFFSET			SIGN FACING			MOUNTING HEIGHT			REFERENCE SHEET NO.		
	A	B	C	A	B	C	A	B	C	A	B	C
IB STA. 604+60 (LOOKING AHEAD)	13'-0"	20'-0"	20'-0"	IB	IB	OB	18'-6"	17'-0"	17'-0"	TXI	TXI	TXI
OB STA. 602+50 (LOOKING BACK)	13'-0"	20'-0"	—	OB	IB	—	18'-6"	17'-0"	—	TXI	TXI	—
OB STA. 257+50 (LOOKING BACK)	—	20'-0"	—	—	IB	—	—	17'-0"	—	—	TX6	—

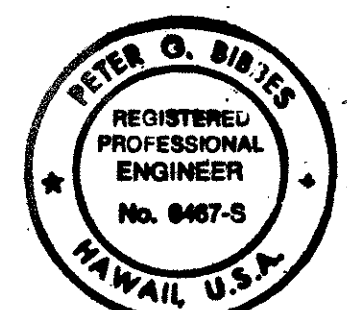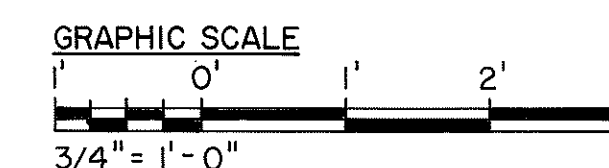

THIS WORK WAS PREPARED BY ME
OR UNDER MY SUPERVISION

DATE	3/22/93	REVISION	REVISED ANCHOR POINT DIMENSIONS PER DEN NO. 66-002
STATE OF HAWAII DEPARTMENT OF TRANSPORTATION HIGHWAYS DIVISION			
MISCELLANEOUS DETAILS - 8			
SUPPORT STRUCTURES INTERSTATE ROUTE H-3 F.A.I. PROJ. NO. I-H3-1 (66)			
SCALE: 3/4" = 1'-0" DATE: APR 1992			
SHEET NO. SS36 OF 36 SHEETS			