

INDEX TO DRAWINGS	
SHEET NO.	DESCRIPTION
1	TITLE SHEET
2	STANDARD PLANS SUMMARY
3-6	GENERAL PLANS
7-11	TYPICAL SECTIONS
12-44	ROADWAY PLAN & PROFILE
45-53	SUPERELEVATION DIAGRAM
54-58	MISCELLANEOUS ROADWAY DETAILS
59	SOIL STABILIZATION DETAILS
60-92	GRADING NOTES AND PLANS
93-141	DRAINAGE PLANS AND DETAILS
142-147	UTILITY RELOCATION PLAN & DETAILS
148-149	WINDWARD HIGHWAY CONNECTION
150-154	HOSPITAL ROCK PAVEMENT REPLACEMENT PLAN
155-195	BORING LOCATION PLAN AND LOGS
196-267	VIADUCT STRUCTURE
268-290	RAMP B
291-323	MISCELLANEOUS STRUCTURAL DETAILS
324-356	ELECTRICAL PLANS AND DETAILS
357-375	TRAFFIC SIGNING, MARKING PLANS AND DETAILS
376-498	CROSS SECTIONS
499-521	DETOUR PLANS

SHTS ADDED (CONT.)
81S-8A
81S-9A
87S-1
120S-1 - 120S-3
123S-1 - 123S-2
126S-1 - 126S-2
129S-1
133S-1
137S-1 - 137S-2
154S-1 - 154S-3
196S-1 - 196S-152
196S-132A
303S-1
320S-1
335S-1 - 335S-7
336S-1
342S-1 - 342S-11
343S-1 - 343S-6
344S-1
346S-1 - 346S-2
347S-1 - 347S-2
348S-1
368S-1 - 368S-3
500S-1 - 500S-3
501S-1 - 501S-3
514S-1 - 514S-20
521S-1 - 521S-4

"AS-BUILT PLANS"

STATE OF HAWAII
DEPARTMENT OF TRANSPORTATION
HIGHWAYS DIVISION
HONOLULU, HAWAII

PLANS FOR CONSTRUCTION OF A PORTION OF INTERSTATE ROUTE H-3 KANEOHE INTERCHANGE

FEDERAL AID INTERSTATE PROJECT NO. I-H3-1(72)




DISTRICT OF KOOLAUPOKO
ISLAND OF OAHU

TOTAL SHEET COUNT AFTER "AS-BUILT" POSTING.
745 SHEETS.


① PLAN SHEET NOS. 355 & 356 WERE NEVER PART OF THIS PROJECT.

SHEETS ADDED			SHEETS DELETED
59S-1 - 59S-3	139S-1-139S-2	352S-1	349 - 354 356①
78S-1 - 78S-2	140S-1	516S-1	355 356 112
81S-1 - 81S- 3 31	149S-1	6S-1	505 - 512 519
92S-1 - 92S-24	312S-1-312S-2	10S-1	81S-2
102S-1 - 102S-4	323S-1 - 323S- 9 9	17S-1	124S-2
110S-1 - 110S-9	334S-1	18S-1	137S-1 - 137S-2
124S-1-124S-3	340S-1 - 340S- 27 27	57S-1	196 - 298
125S-1-125S-3	349S-1 - 349S-2	65S-1 - 65S-11	323S-1 - 323S-8
131S-1 - 131S-2	351S-1	75S-1 - 75S-4	500S-2 & 516S-1

FED. ROAD DIST. NO.	STATE	FED. AID PROJ. NO.	FISCAL YEAR	SHEET NO.	TOTAL SHEETS
HAWAII	HAW.	I-H3-1(72)	1991	ADD. 1	521

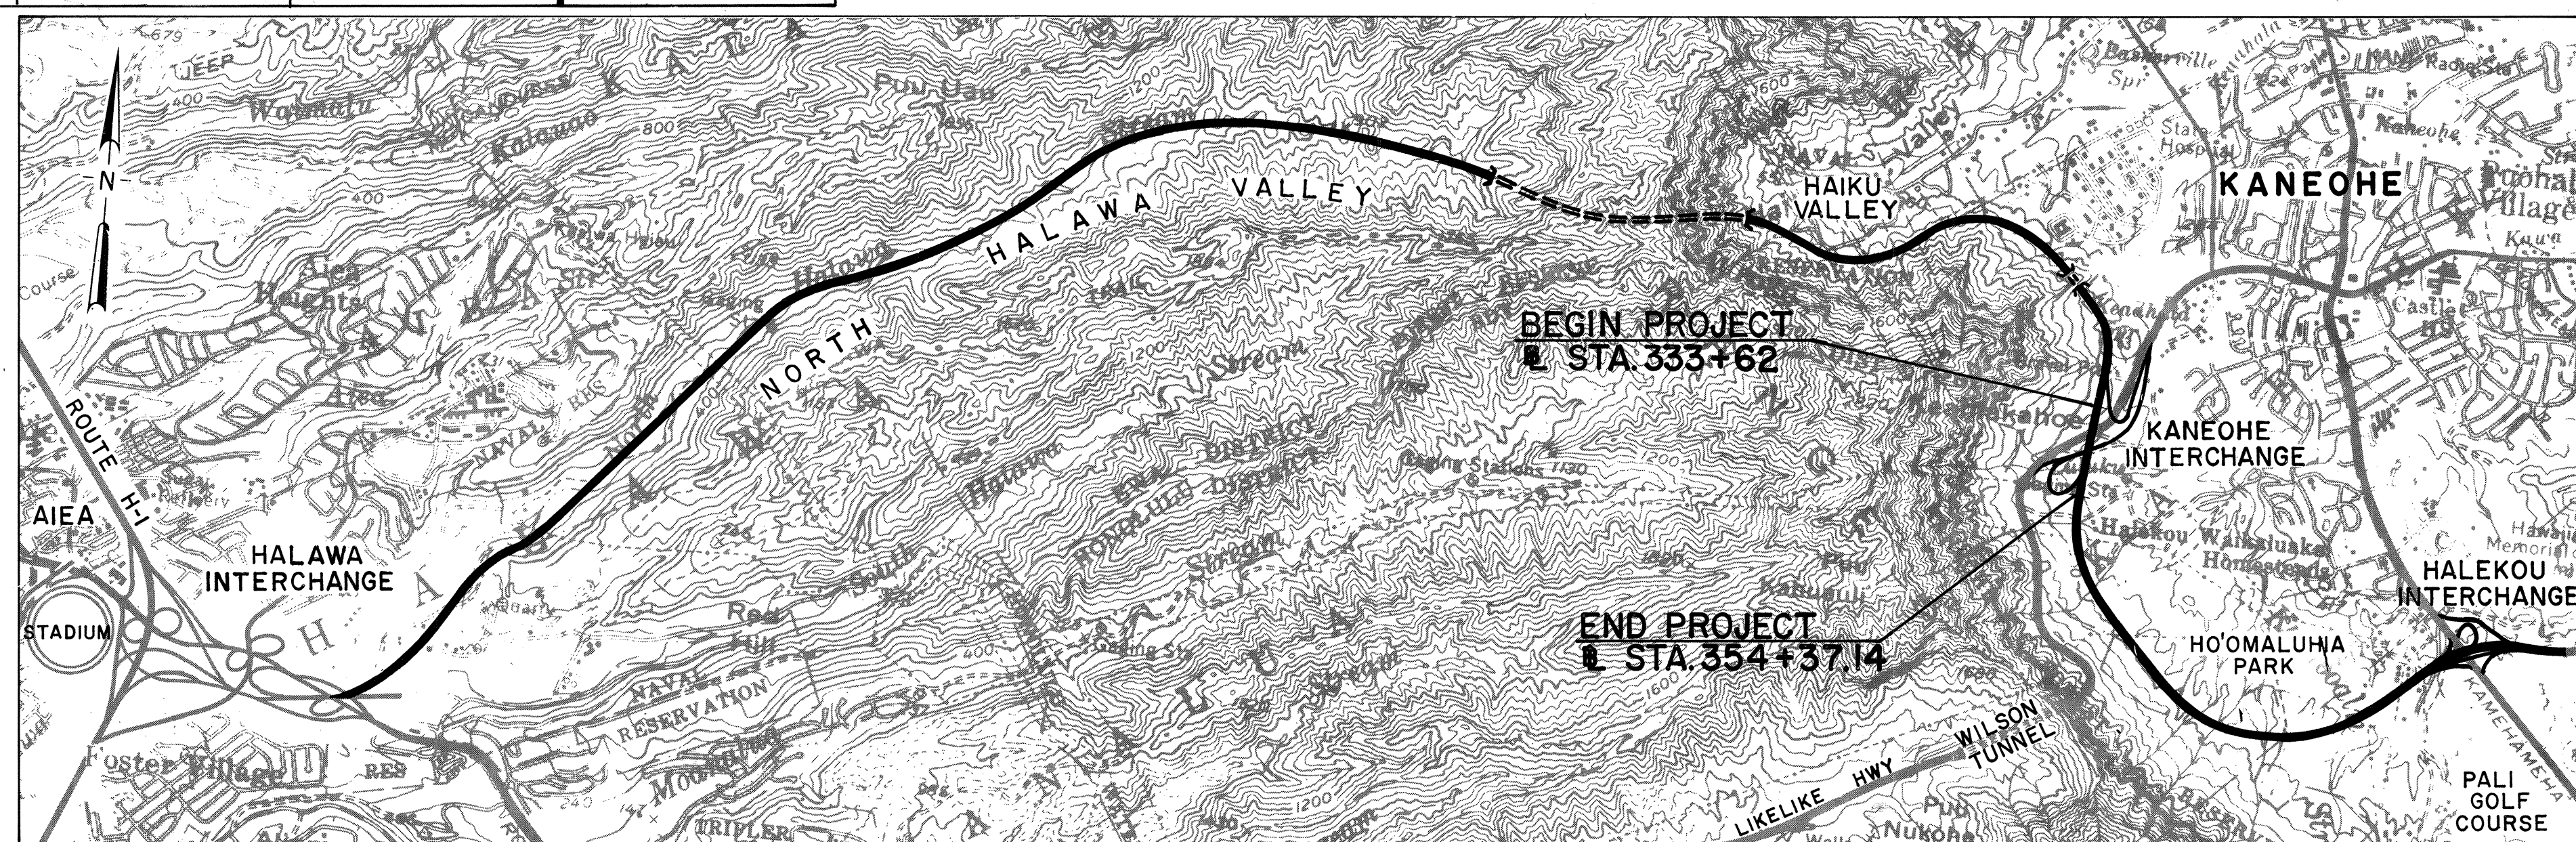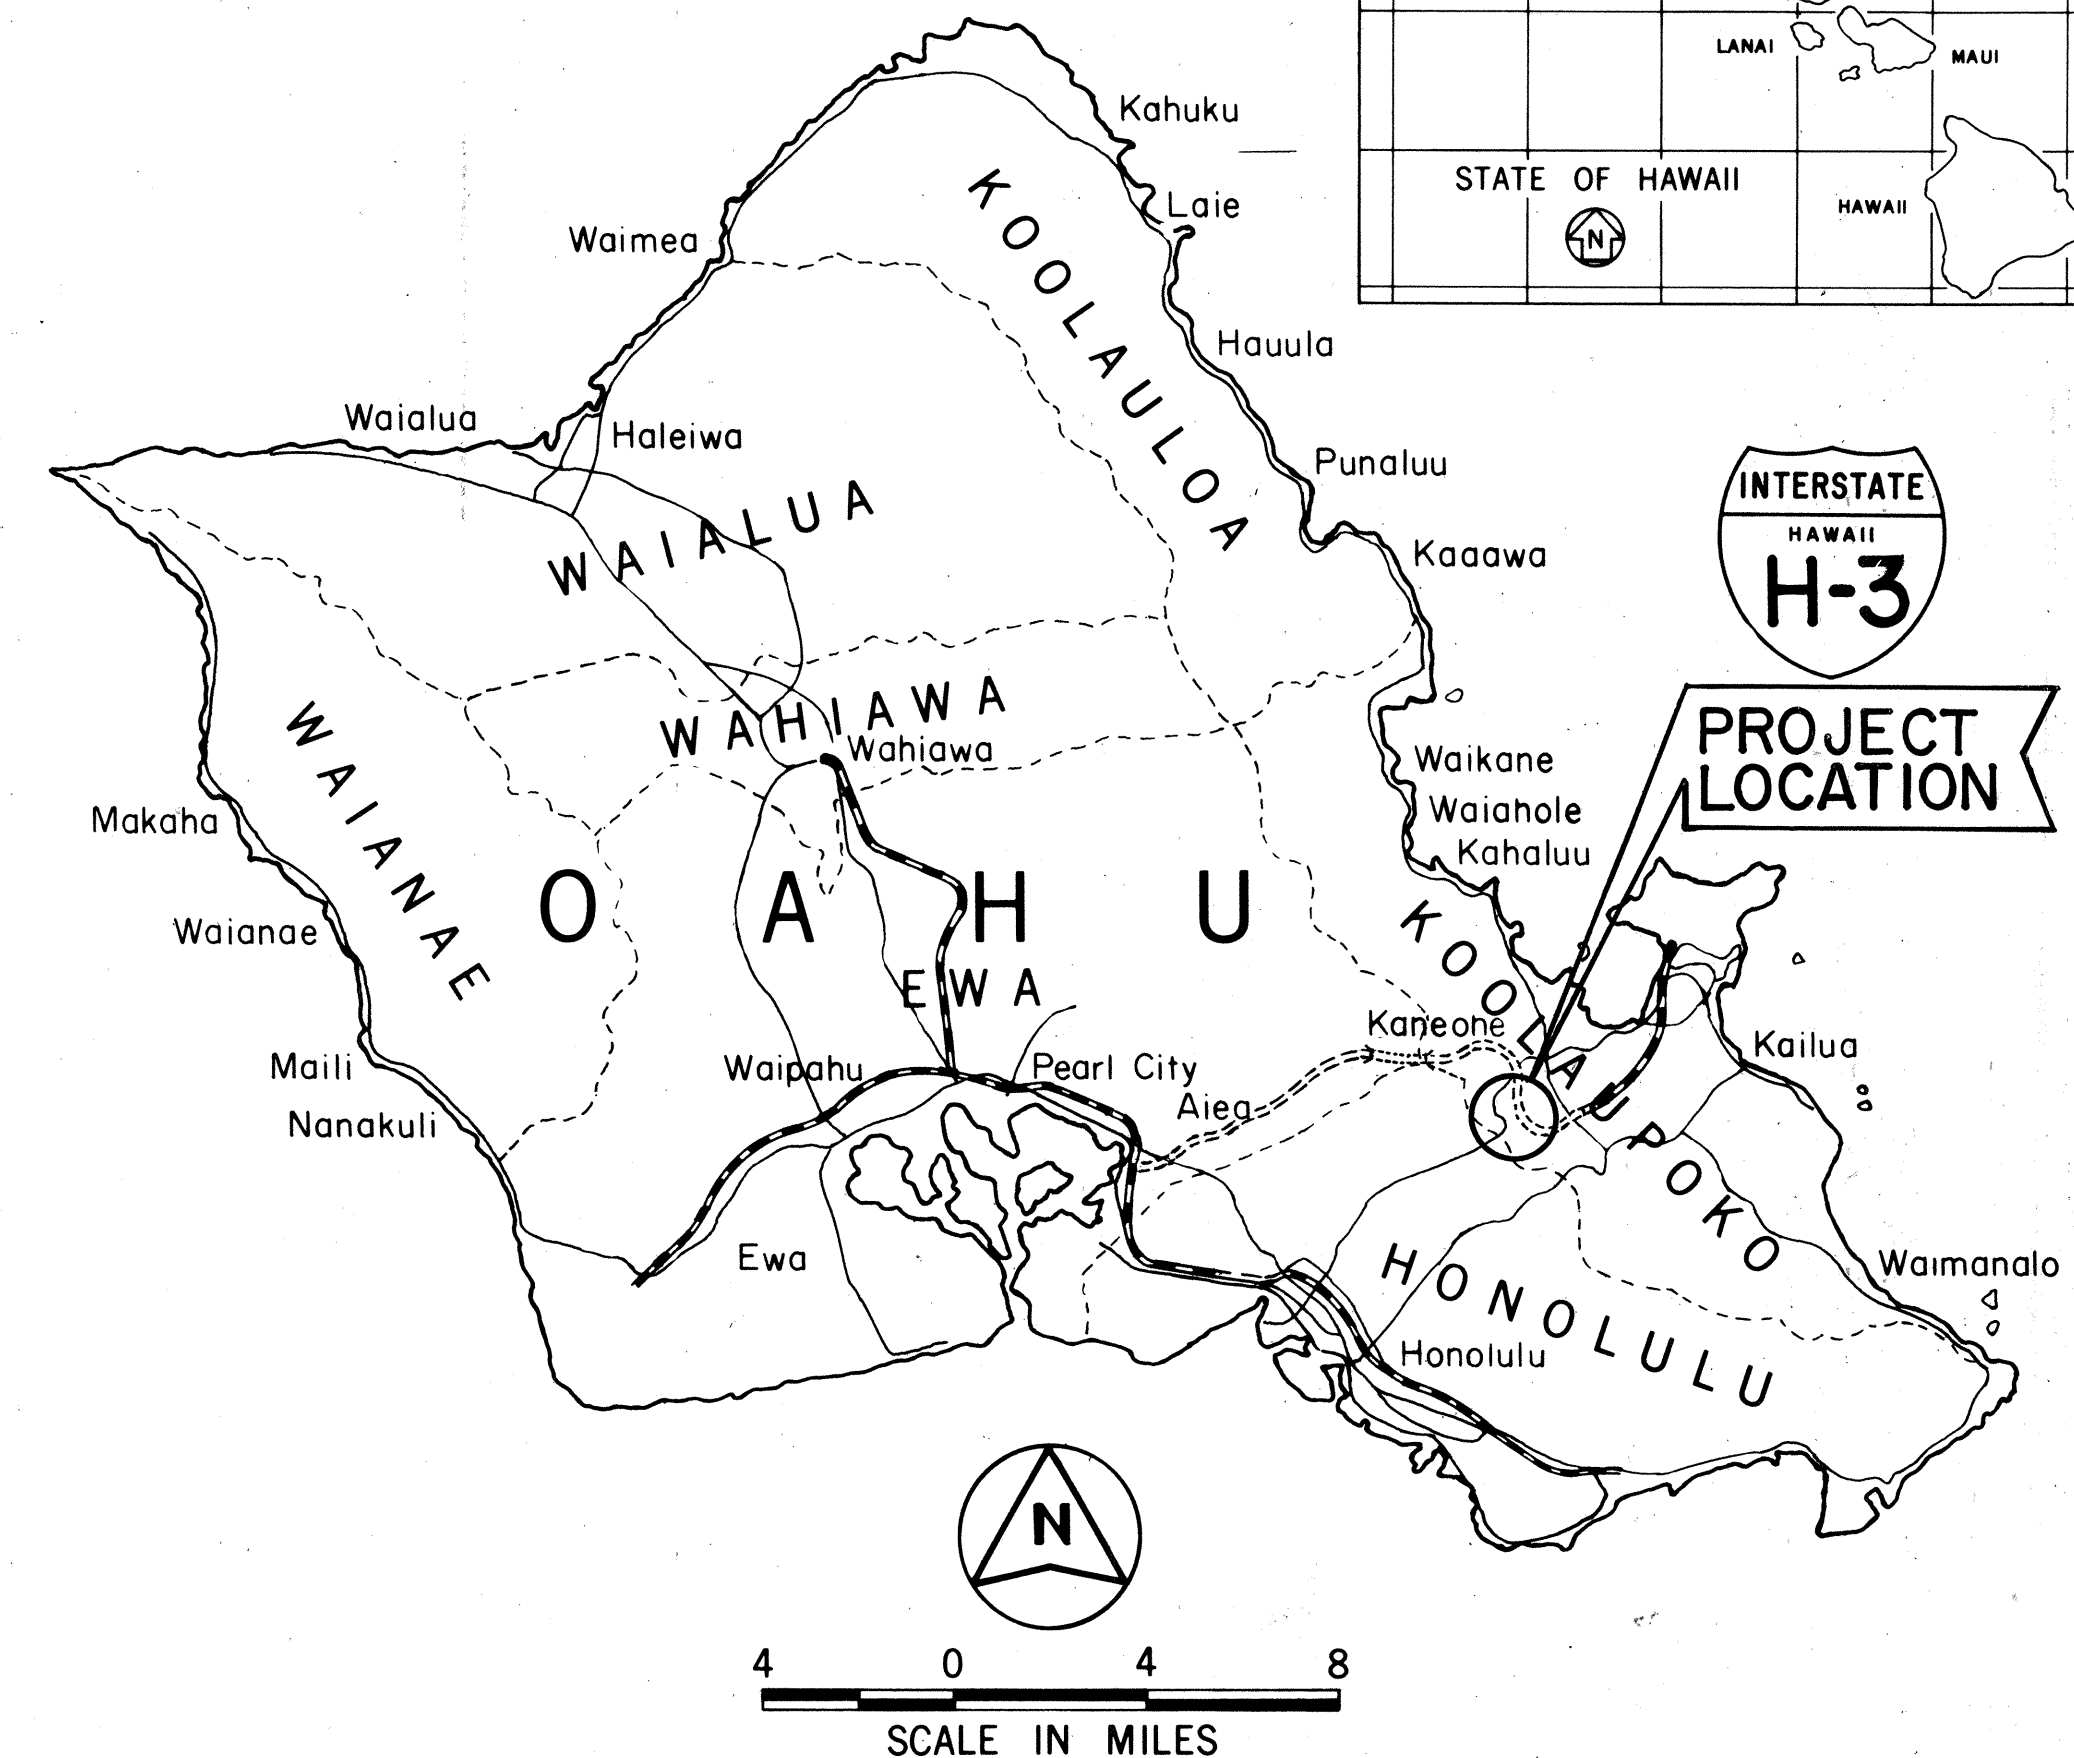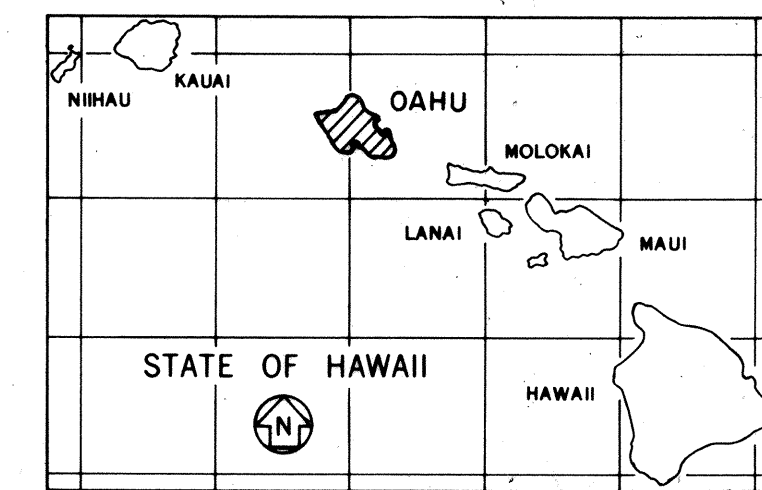

LAYOUT PLAN

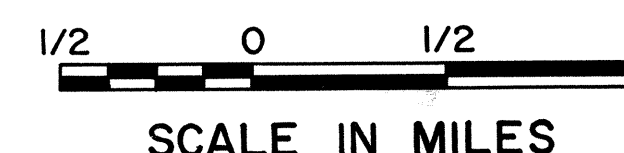

GROSS LENGTH OF PROJECT: INTERSTATE ROUTE H3-----0.4 MILES
LIKELIKE HIGHWAY-----1.2 MILES
(TO ANOI ROAD)

FEDERAL AID INTERSTATE PROJECTS PREVIOUSLY CONSTRUCTED OR UNDER CONSTRUCTION

DESIGN DESIGNATION

FUTURE ADT (1998)-----	39,430
DESIGN ADT (2008)-----	45,220
DHV-----	4,282
D-----	76/24
T-----	2.1%
T24-----	4.1%
V-----	60 M.P.H.

CHANGES MADE DURING CONSTRUCTION HAVE BEEN INCORPORATED ON THESE PLANS EXCEPT CHANGES IN THE ORIGINAL THEORETICAL QUANTITIES. FOR ACTUAL QUANTITIES, REFER TO PROJECT LEDGER AND/OR COMPUTATION BOOK.

3/27/92	Revised Index for Sheets Added and Deleted.
2/21/92	Added Index for Sheets Added and Sheets Deleted
DATE	REVISION

Myra P. P.
RESIDENT ENGINEER 11/2/96 DATE

DEPARTMENT OF TRANSPORTATION
FEDERAL HIGHWAY ADMINISTRATION
APPROVED:
Raymond J. McCarroll
DIVISION ADMINISTRATOR 12/19/91 DATE

DEPARTMENT OF TRANSPORTATION
STATE OF HAWAII
APPROVED:
Raymond J. McCarroll
DIR. OF TRANSPORTATION 12/17/91 DATE

ENGINEERS
SURVEYORS HAWAII, INC.
DESIGNED BY
CLARENCE YAMAMOTO
P. S. & E. BY
587-2209 PHONE
DEC. 1991 DATE