

INDEX TO DRAWINGS	
COMPOSITE AND SET SHEET NO	DESCRIPTION
1	TITLE SHEET
2-8	TYPICAL RDWY SECTIONS (1)
9-34	PLAN & PROFILE AND S.E. DIAG.
35-36	MOKAPU INTERCHANGE GRADING PLAN
37-38	KANEOHE BAY LOOKOUT DETAILS
39-42	HECo AND HTCo ACCESS ROAD DETAILS (2)
43-51, 51A-51E	MISCELLANEOUS ROADWAY DETAILS
51F, 51G, 52, 53, 53A, 54-73, 73A-73F	PAVEMENT MARKINGS & SIGNING PLANS AND DETAILS
74-94, 94A-94C, 95-100	DRAINAGE PLANS & DETAILS (3)
101-120, 120A	MOKAPU INTERCHANGE STRUCTURE PLANS & DETAILS (4)
121-234	CROSS SECTIONS
121-220	BASELINE
221-228	RAMPS
229-234	KANEOHE BAY DRIVE
235-241	LANDSCAPE PLANS
242-247	HIGHWAY LIGHTING PLANS AND DETAILS
248-260	UTILITIES PLANS & DETAILS
C.O.260S-1- C.O.260S-44 & C.O.260S-33A	SPRINKLER SYSTEM
C.O. 261	PLAN & DETAILS OF NESTING & FEEDING SITES FOR ENDANGERED WATER BIRDS

SUPPLEMENTARY SHEETS TO THIS PROJECT ARE SHEET NOS.

- (1) C.O. 5 S-1
(2) C.O. 39 S-1
(3) C.O. 90 S-1, C.O. 100 S-1, C.O. 100 S-2
(4) C.O. 112 S-1

STATE OF HAWAII
DEPARTMENT OF TRANSPORTATION
HIGHWAYS DIVISION
HONOLULU, HAWAII
"AS - BUILT"
PLANS FOR
CONSTRUCTION OF A PORTION OF
INTERSTATE ROUTE H-3


KAILUA INTERCHANGE TO KANEOHE MARINE CORPS A.S.

FEDERAL AID INTERSTATE PROJECT No. I-H3-1(8):14
AND
FEDERAL AID INTERSTATE PROJECT No. I-H3-1(2):8

DISTRICT OF KOOLAUPOKO
ISLAND OF OAHU

TOTAL SHEET COUNT AFTER
"AS-BUILT" POSTINGS: 330 SHEETS

FED. ROAD DIST. NO.	STATE	FED. AID PROJ. NO.	FISCAL YEAR	SHEET NO.	TOTAL SHEETS
HAWAII	HAW.	I-H3-1(8):14 I-H3-1(2):8	1969	1	280

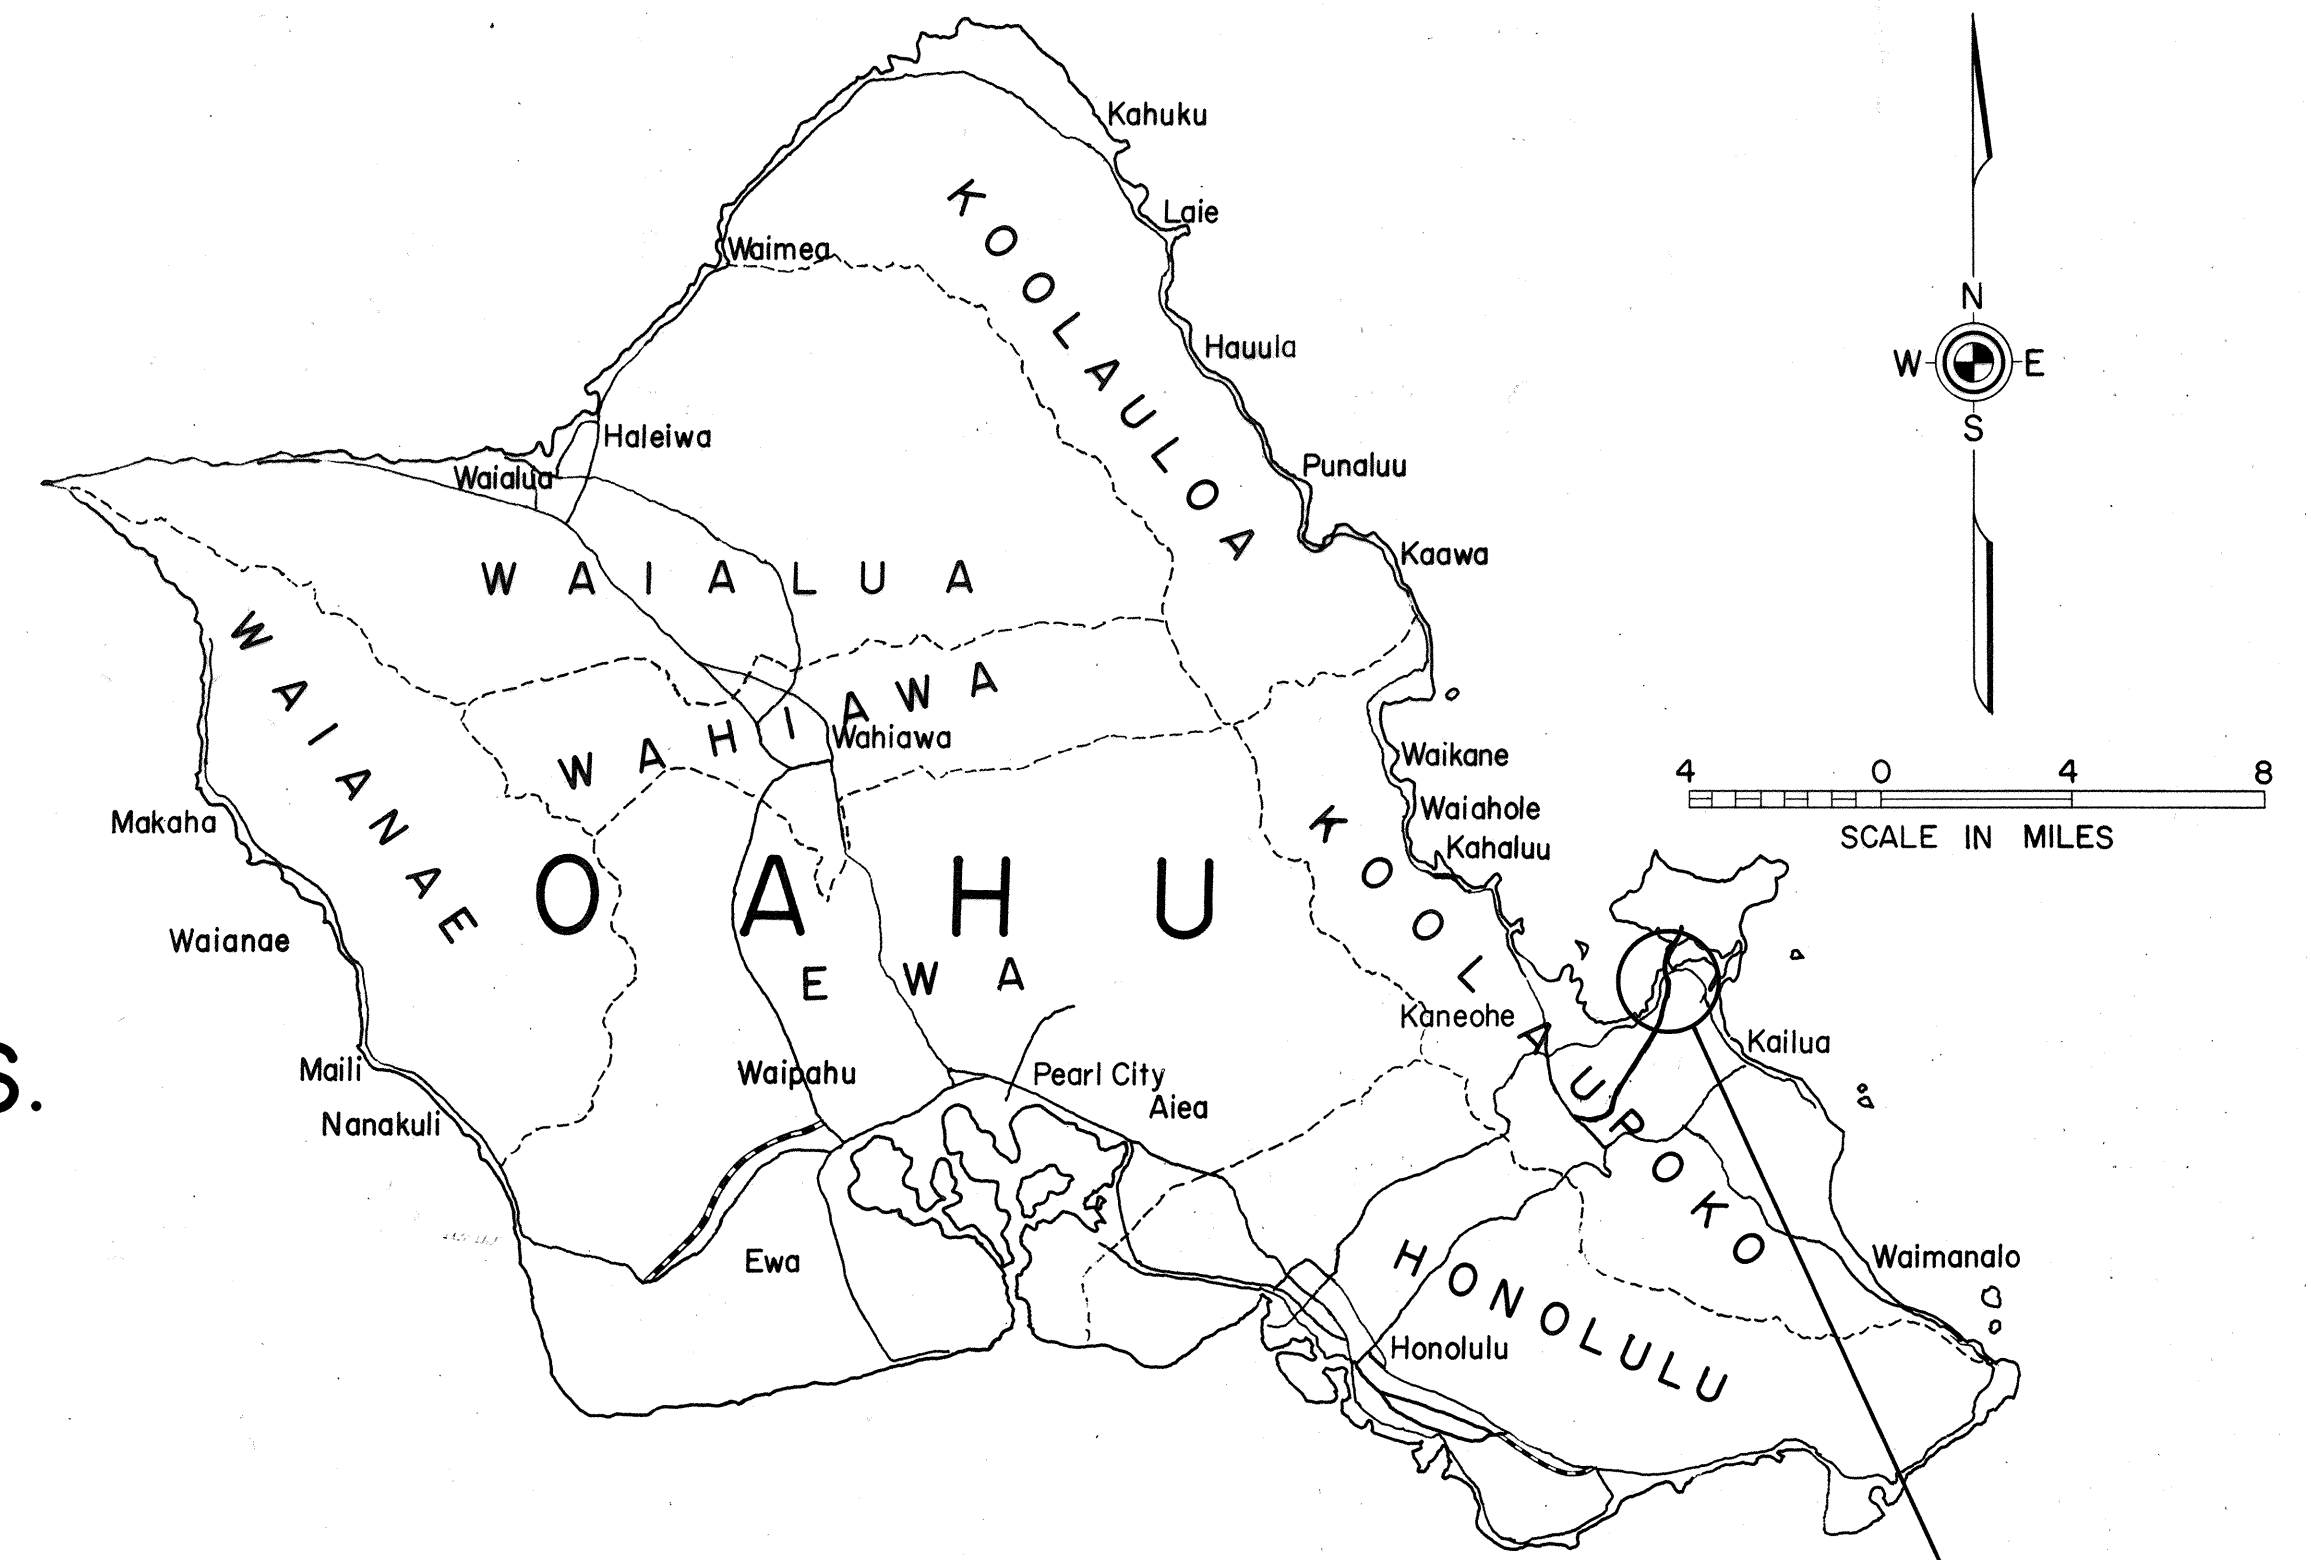

LOCATION OF PROJECT
F.A.I. PROJ. No. I-H3-1(8):14
F.A.I. PROJ. No. I-H3-1(2):8
Federal Aid Interstate Projects Previously Constructed or Under Construction

