

INDEX TO DRAWINGS		
COMPOSITE SHEET NO.	DESCRIPTION	SET SHEET NO.
84	TITLE SHEET	1
85-87	TYPICAL RDWY SECTIONS	2-4
88-95	ROADWAY PLANS AND PROFILES	5-12
96	KAILUA INTERCHANGE GRADING PLAN	13
12-18, 18A, 18B, 97-98	MISC. RDWY DETAILS	14-15
99-101	PLAN AND PROFILE KAPAA RESERVOIR ACCESS RD	16-18
29, 102-110	DRAINAGE PLANS	19-27
44-52, 111-114	UTILITY PLANS	28-31
55-57, 60-62, 115-122	TRAFFIC SIGN PLANS	32-39
123-125	HIGHWAY LIGHTING PLANS	40-42
126-138	KAILUA INTERCHANGE STRUCTURE	43-55
139-141*	LANDSCAPE PLANS	56-58*
142-169	CROSS SECTIONS	59-86
113A	REVISED WATER LINE	
*C.O. 141 S-I, C.O. 141S-10	SPRINKLER SYSTEM	*C.O. 58S-I, C.O. 58S-10

STATE OF HAWAII

DEPARTMENT OF TRANSPORTATION

HIGHWAYS DIVISION

HONOLULU, HAWAII

"AS BUILT"

PLANS FOR

CONSTRUCTION OF A PORTION OF

INTERSTATE ROUTE H-3

KAILUA INTERCHANGE


FEDERAL AID INTERSTATE PROJECT No I-H3-1(7):13

AND

FEDERAL AID INTERSTATE PROJECT No. I-H3-1(2):8

DISTRICT OF KOOLAUPOKO

ISLAND OF OAHU

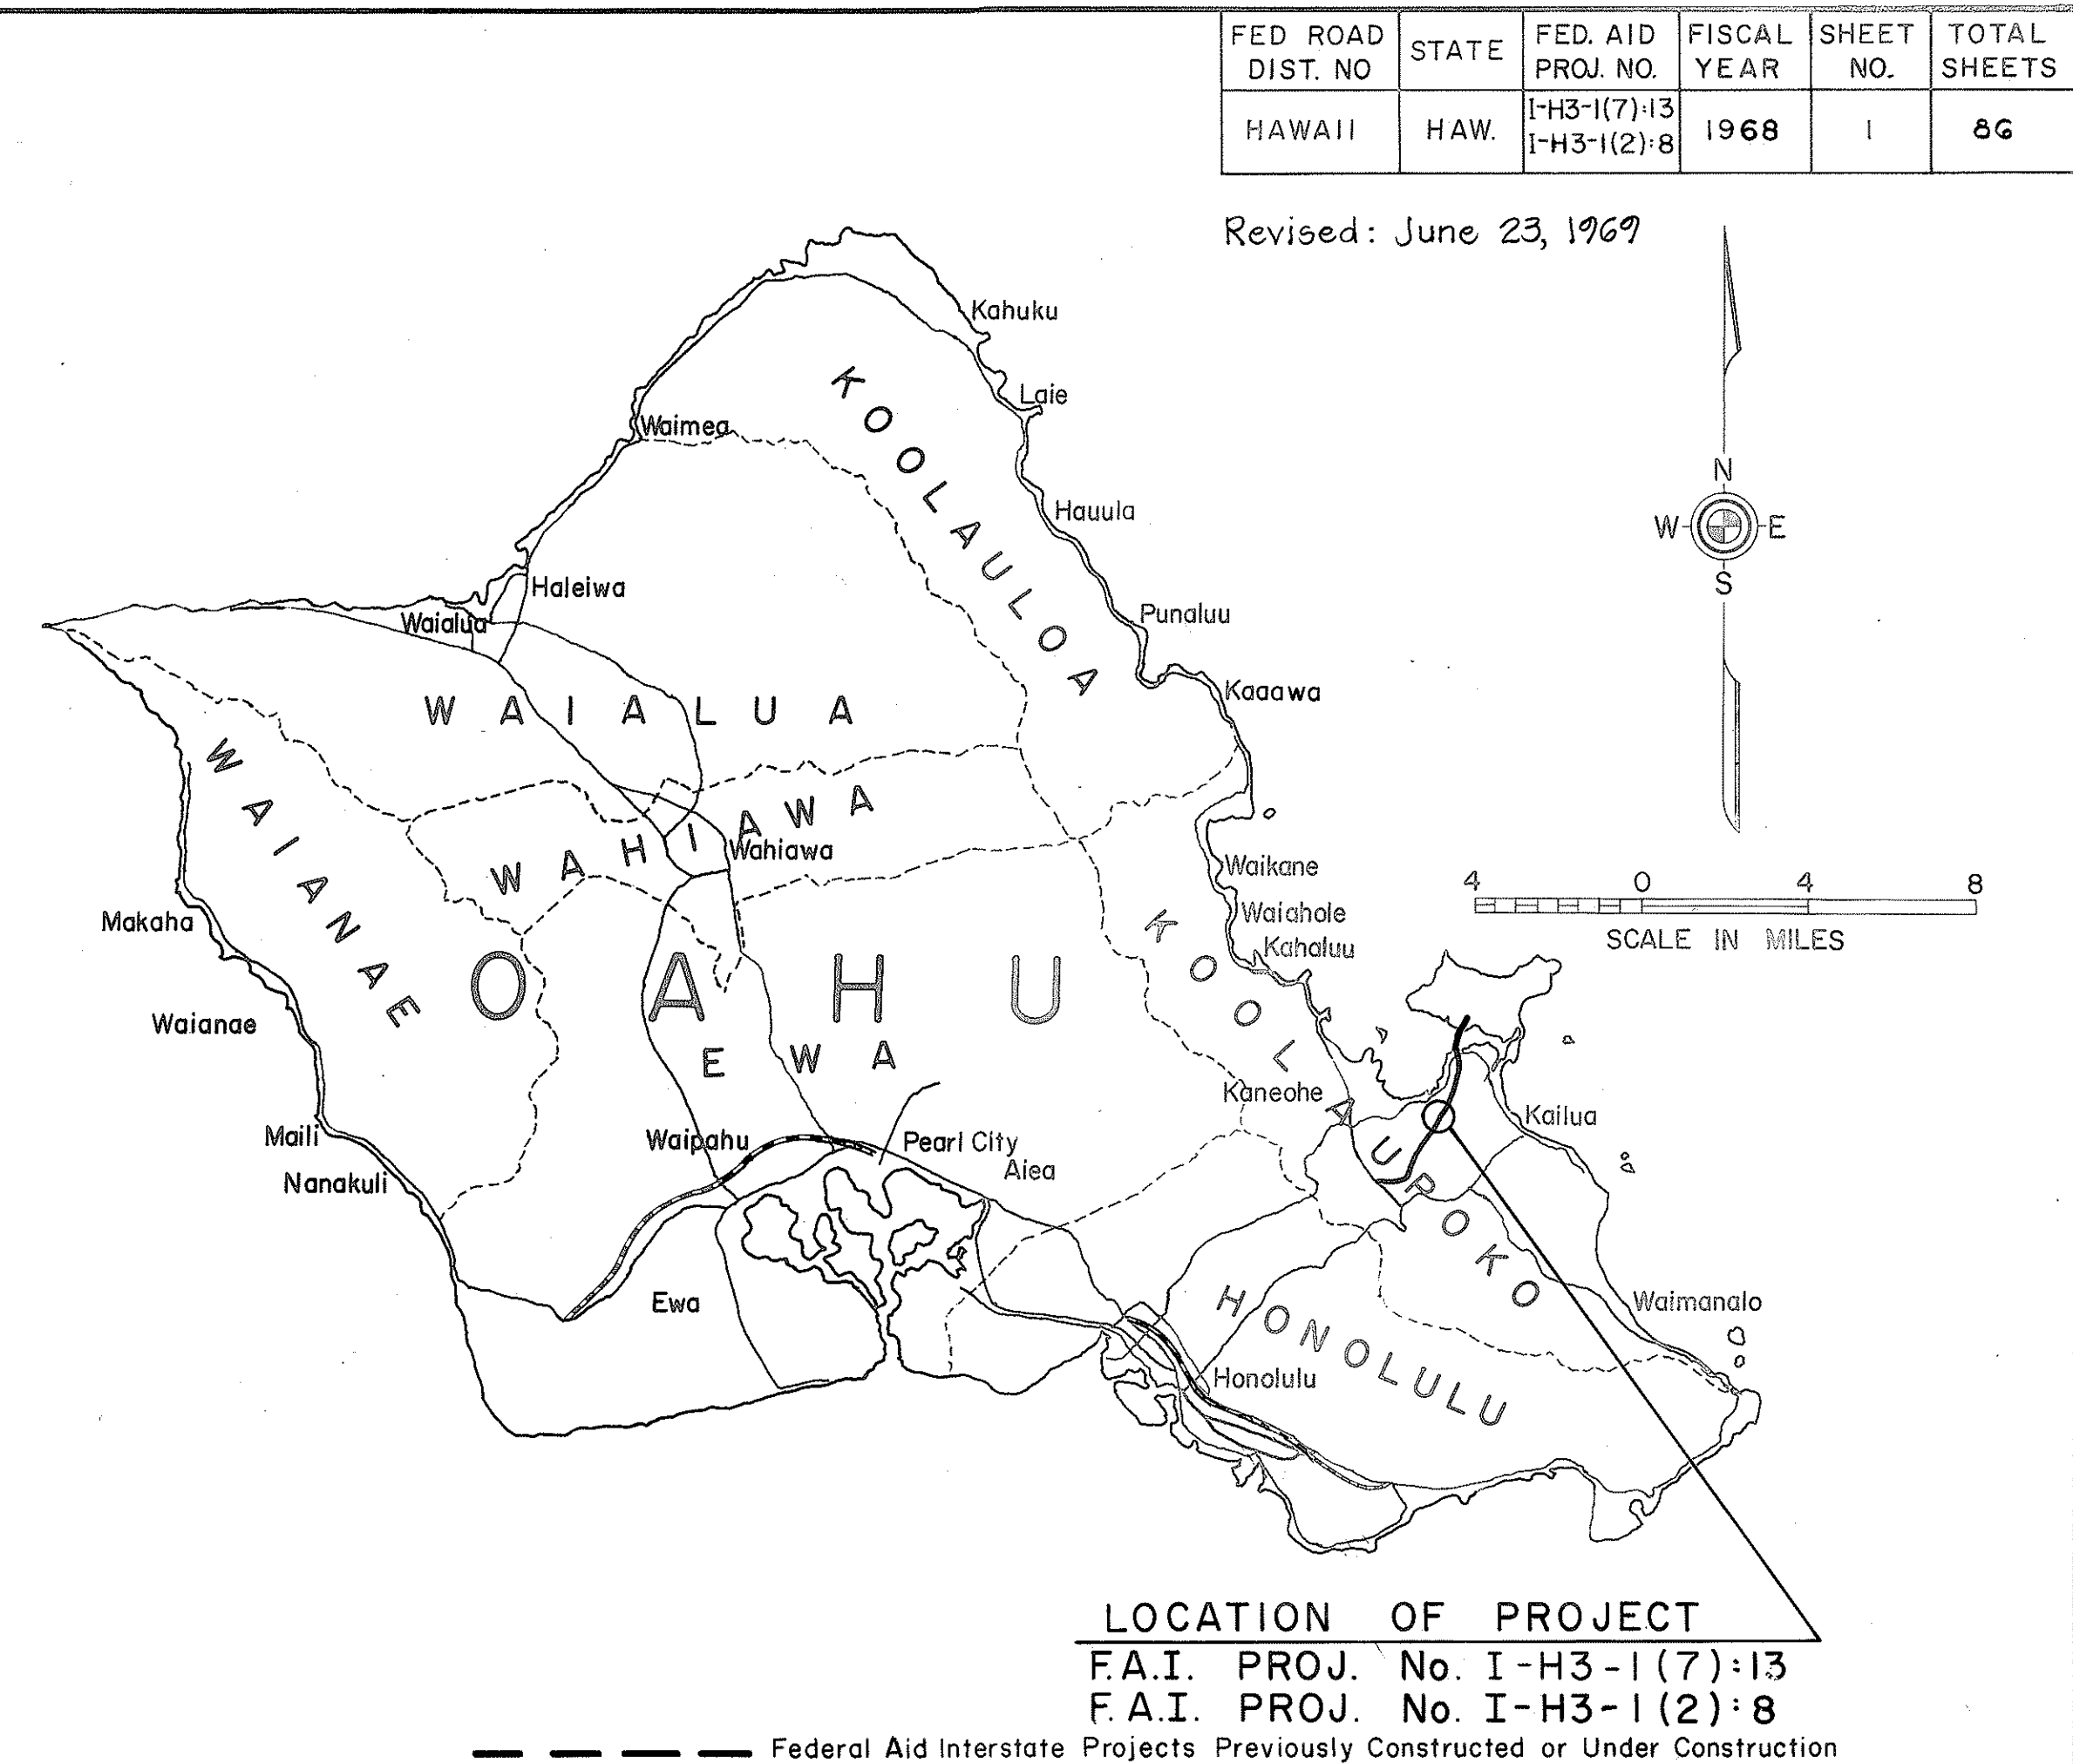

DESIGNED BY: WILSON OKAMOTO & ASSOC. INC.

DATE: APRIL 1969

PHONE: 546-2211 LOC. 301

FS & E BY: SELING FA YUEN

