

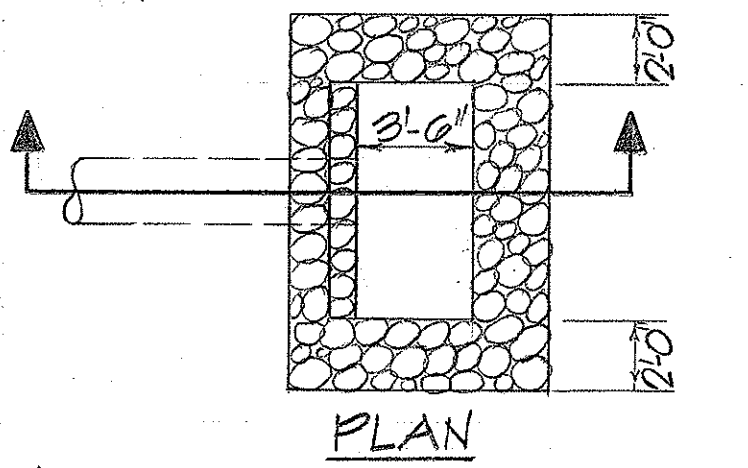
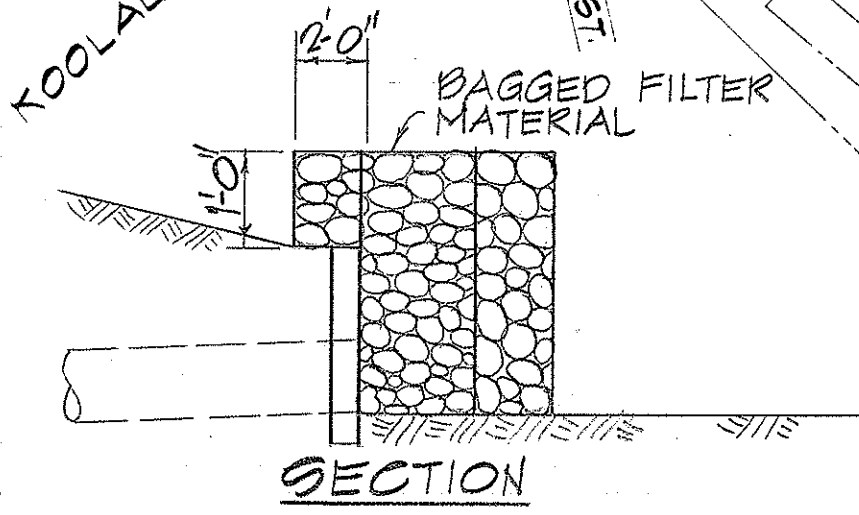
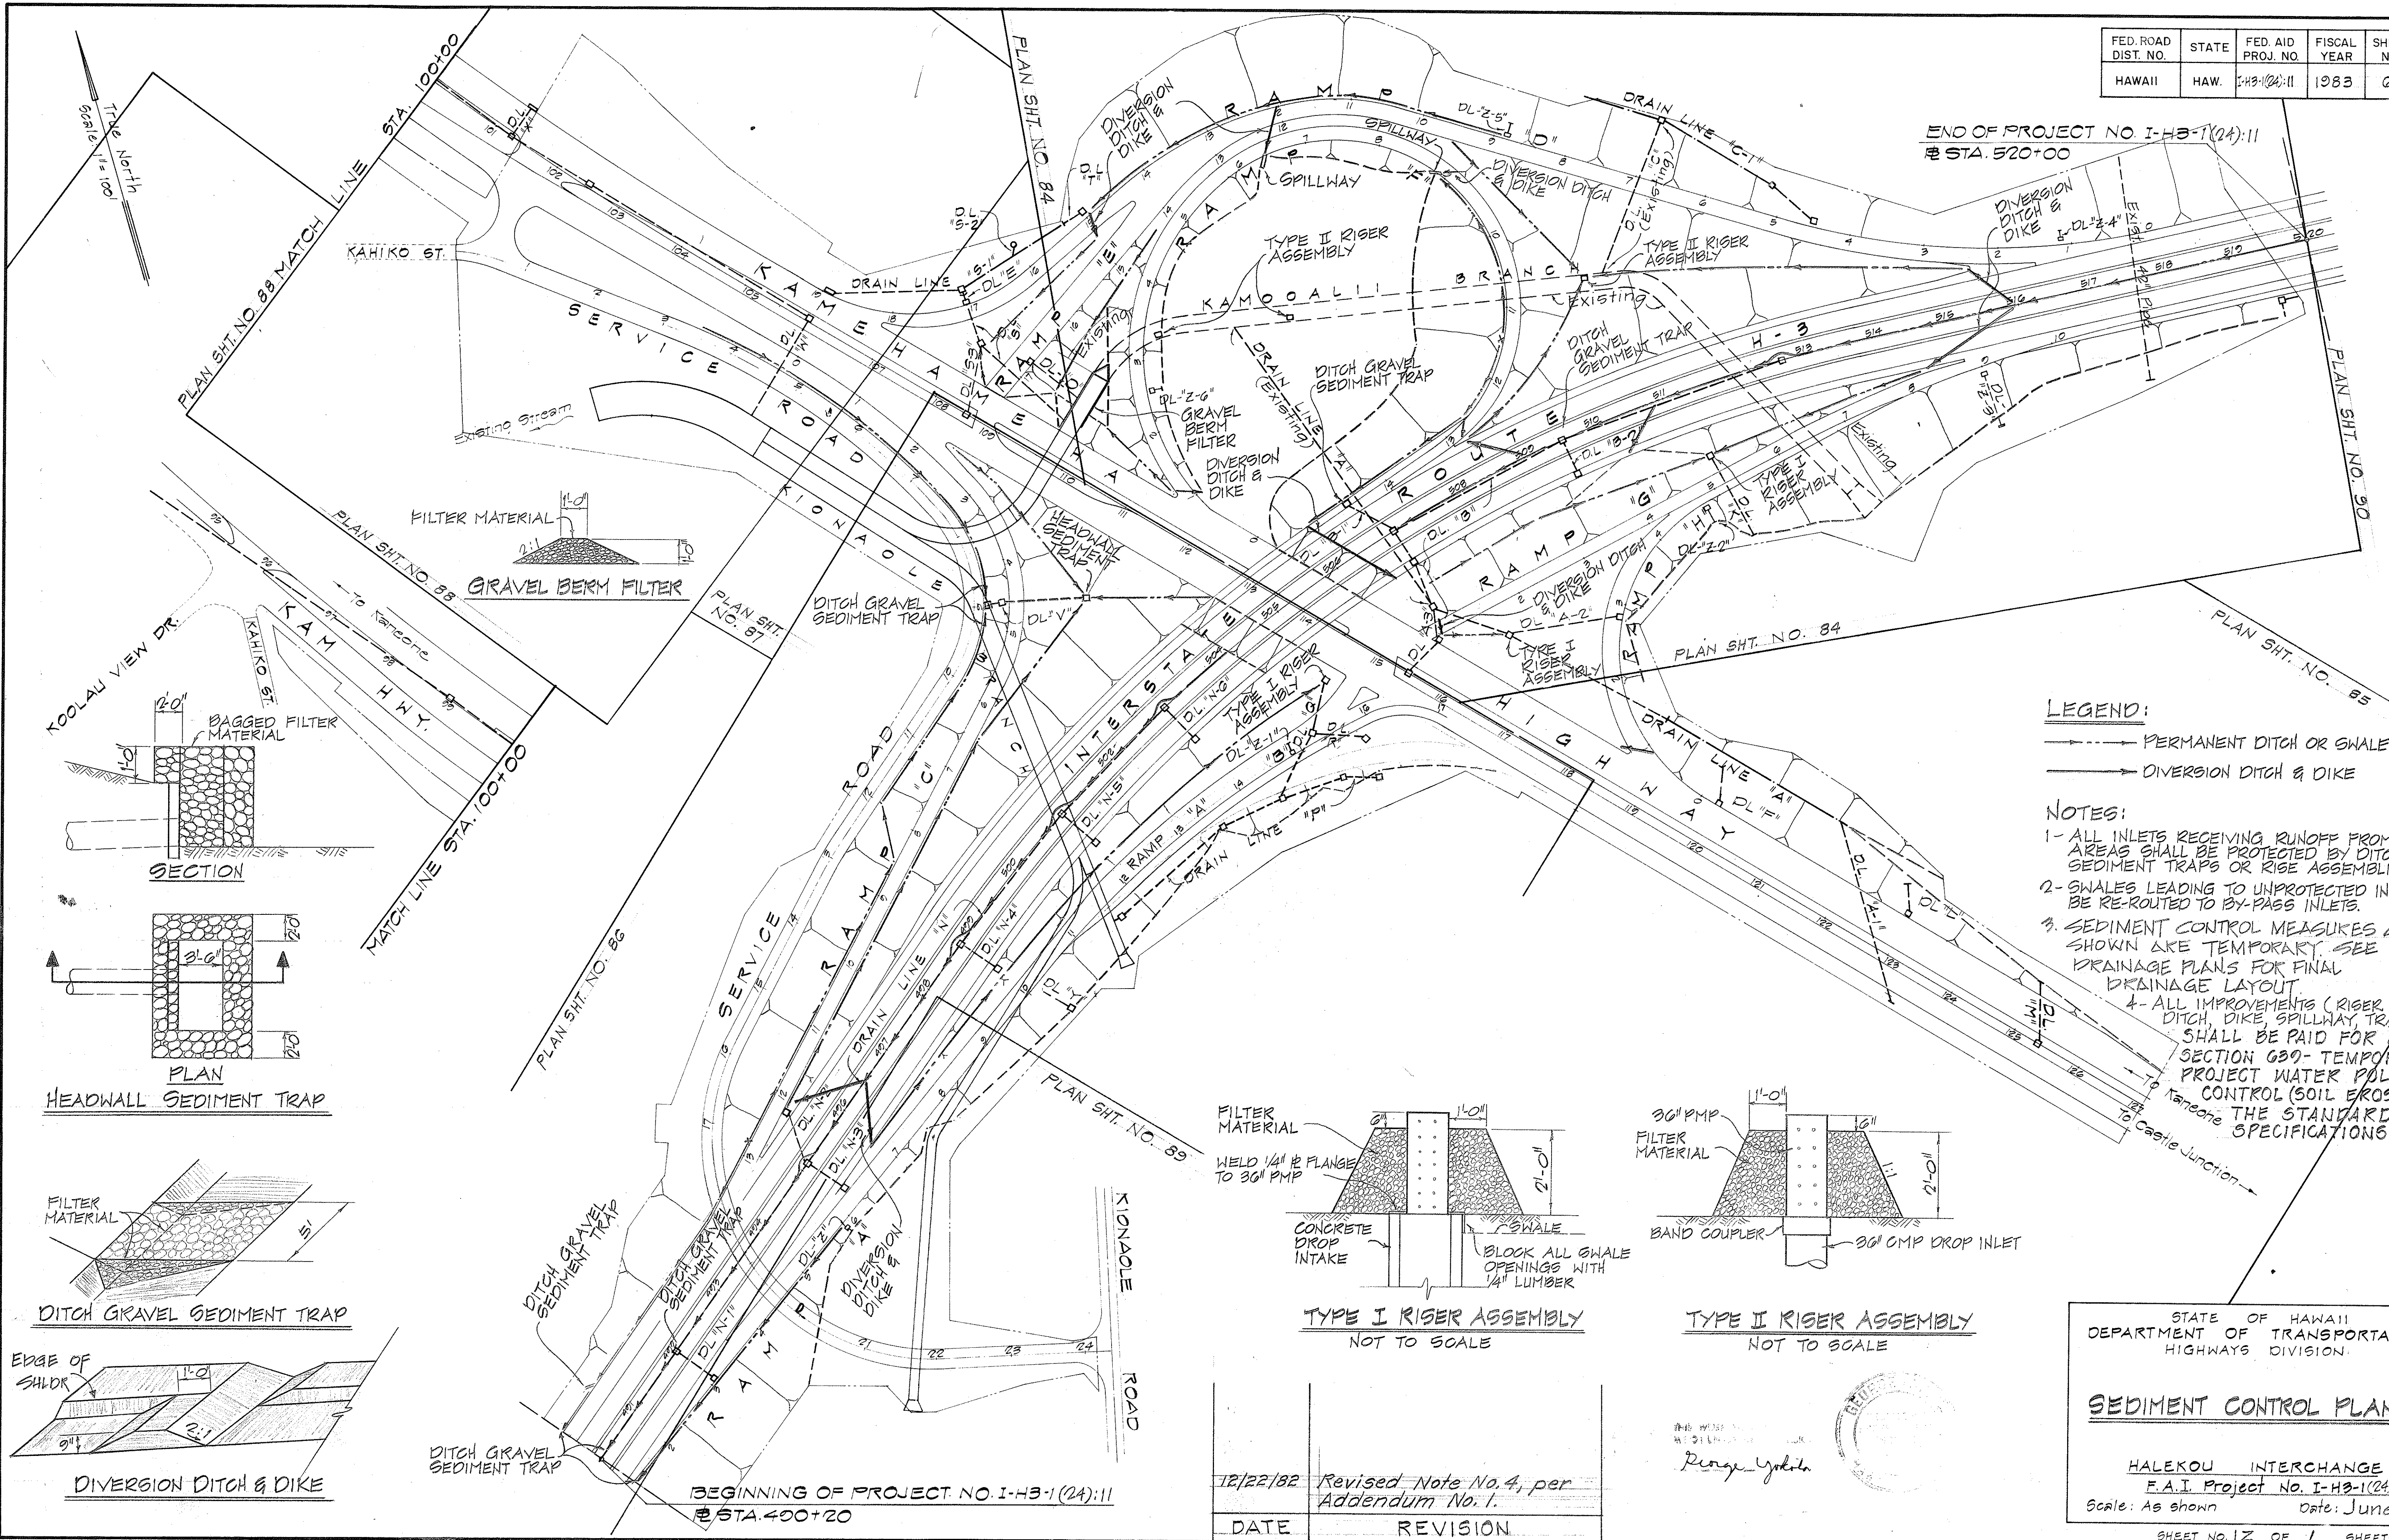


FED. ROAD DIST. NO.	STATE	FED. AID PROJ. NO.	FISCAL YEAR	SHEET NO.	TOTAL SHEETS
HAWAII	HAW.	143-1(24):11	1983	69	328

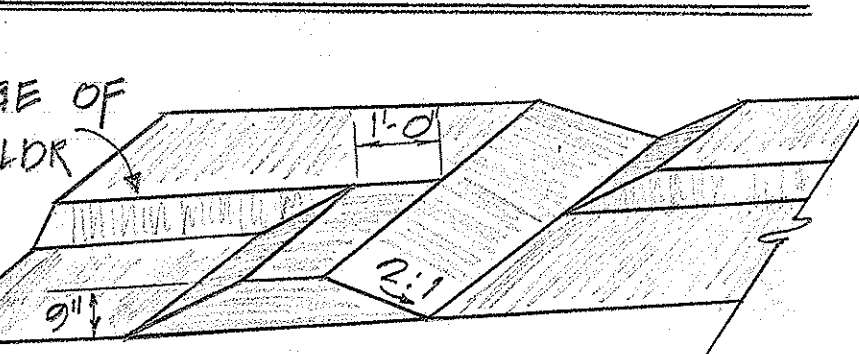

HEADWALL SEDIMENT TRAP

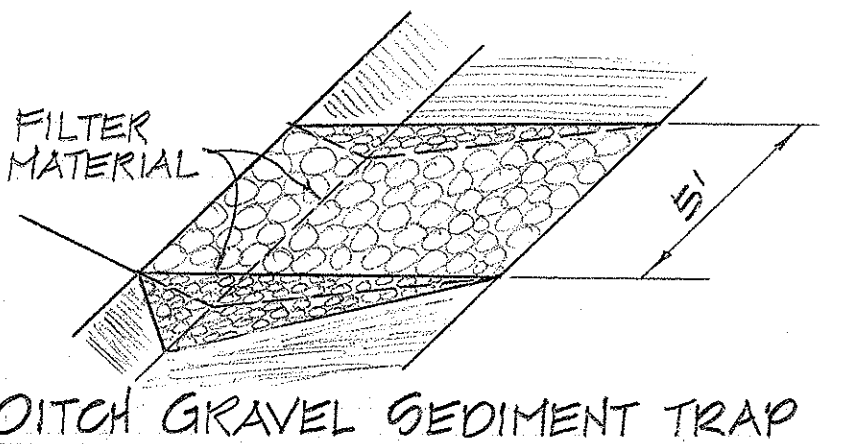


DIVERSION DITCH & DIKE

LEGEND:


- PERMANENT DITCH OR SWALE
- DIVERSION DITCH & DIKE

NOTES:

- ALL INLETS RECEIVING RUNOFF FROM GRADED AREAS SHALL BE PROTECTED BY DITCH GRAVEL SEDIMENT TRAPS OR RISE ASSEMBLIES.
- SWALES LEADING TO UNPROTECTED INLETS SHALL BE RE-ROUTED TO BY-PASS INLETS.
- SEDIMENT CONTROL MEASURES AS SHOWN ARE TEMPORARY. SEE DRAINAGE PLANS FOR FINAL DRAINAGE LAYOUT.
- ALL IMPROVEMENTS (RISE ASSEMBLY, DITCH, DIKE, SPILLWAY, TRAP, FILTER) SHALL BE PAID FOR UNDER SECTION 630- TEMPORARY PROJECT WATER POLLUTION CONTROL (SOIL EROSION) OF THE STANDARD SPECIFICATIONS.

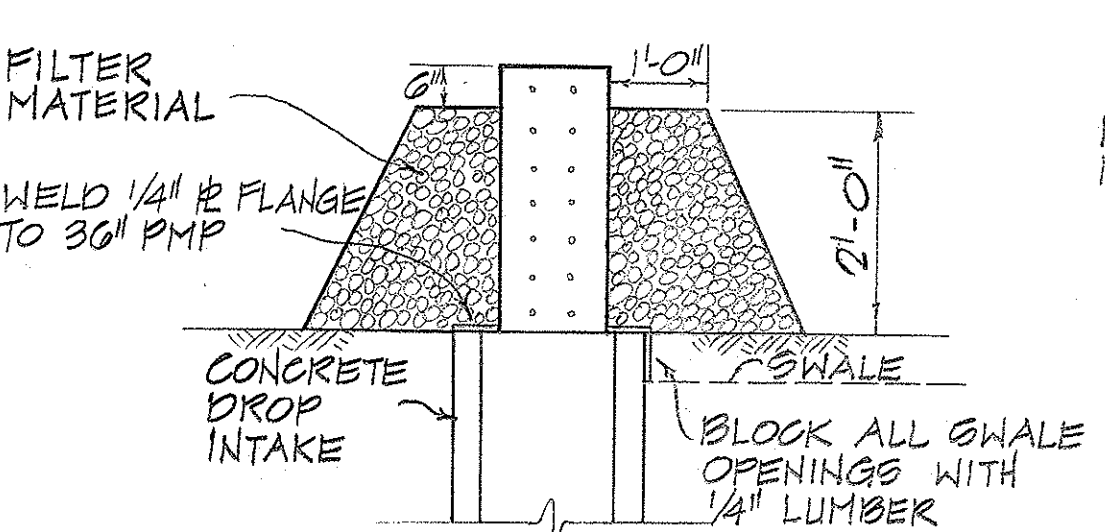

TYPE I RISER ASSEMBLY
NOT TO SCALE

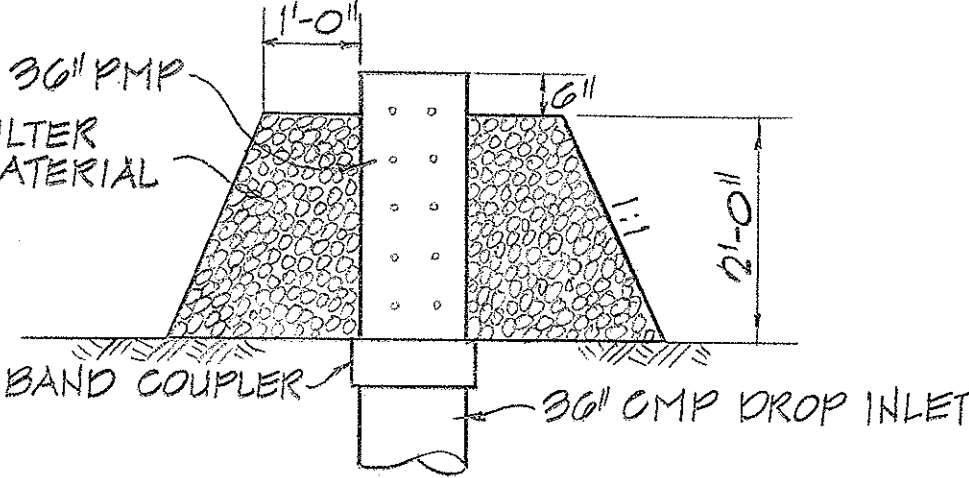

TYPE II RISER ASSEMBLY
NOT TO SCALE

12/22/82	Revised Note No. 4, per Addendum No. 1.
DATE	REVISION

STATE OF HAWAII
DEPARTMENT OF TRANSPORTATION
HIGHWAYS DIVISION

SEDIMENT CONTROL PLAN

HALEKOU INTERCHANGE
F.A.I. Project No. I-H3-1(24):11
Scale: As shown Date: June 1975