

INDEX TO DRAWINGS	
SHEET NO.	DESCRIPTION
1	TITLE SHEET
2 - 6	TYPICAL ROADWAY SECTIONS
7 - 23	SHEET KEY MAP AND PLAN & PROFILE
24 - 28	BORING LOGS
29 - 31	INTERSECTION DETAILS & GRADES
32 - 40	SUPERELEVATION DIAGRAMS
41 - 61	MISCELLANEOUS, TYPICAL & STANDARD ROADWAY DETAILS
62 - 67	CONSTRUCTION SEQUENCE PLANS & DETAIL
68	SURCHARGE PLAN
69	SEDIMENT CONTROL PLAN
70 - 71	UNDERDRAIN PLAN
72 - 130	DRAINAGE PLANS & DETAILS
131 - 136	WATER SYSTEM PLANS
137 - 154	ELECTRIC & TELEPHONE PLANS & DETAILS
155 - 168	HIGHWAY LIGHTING PLANS & DETAILS
169 - 170	HAWAII LOA COLLEGE FORCE MAIN
171	INDEX TO BRIDGE DRAWINGS & LOCATION PLAN
172 - 201	BRIDGE NO. 1 & NO. 2, PLANS & DETAILS
202 - 221	BRIDGE NO. 3, PLANS & DETAILS
222 - 233	KAMOOALII STREAM BRIDGE, PLANS & DETAILS
234	TYPICAL BRIDGE DETAILS
235 - 240	STANDARD BRIDGE DETAILS
241 - 268	TRAFFIC SIGNING, PAVEMENT MARKINGS PLANS & DETAILS
269 - 272	LANDSCAPING PLANS & DETAILS
273 - 275	SPRINKLER SYSTEM
276 - 328	CROSS SECTIONS

STATE OF HAWAII
DEPARTMENT OF TRANSPORTATION
HIGHWAYS DIVISION
HONOLULU, HAWAII

"AS-BUILT"
PLANS FOR
CONSTRUCTION OF A PORTION OF
INTERSTATE ROUTE H-3
HALEKOU INTERCHANGE
FEDERAL AID INTERSTATE PROJECT NO. I-IR-H3-1(24):11

FED. ROAD DIST. NO.
HAWAII


STATE
HAW.

FED. AID PROJ. NO.
I-IR-H3-1(24):11

FISCAL YEAR
1983


SHEET NO.
1

TOTAL SHEETS
328

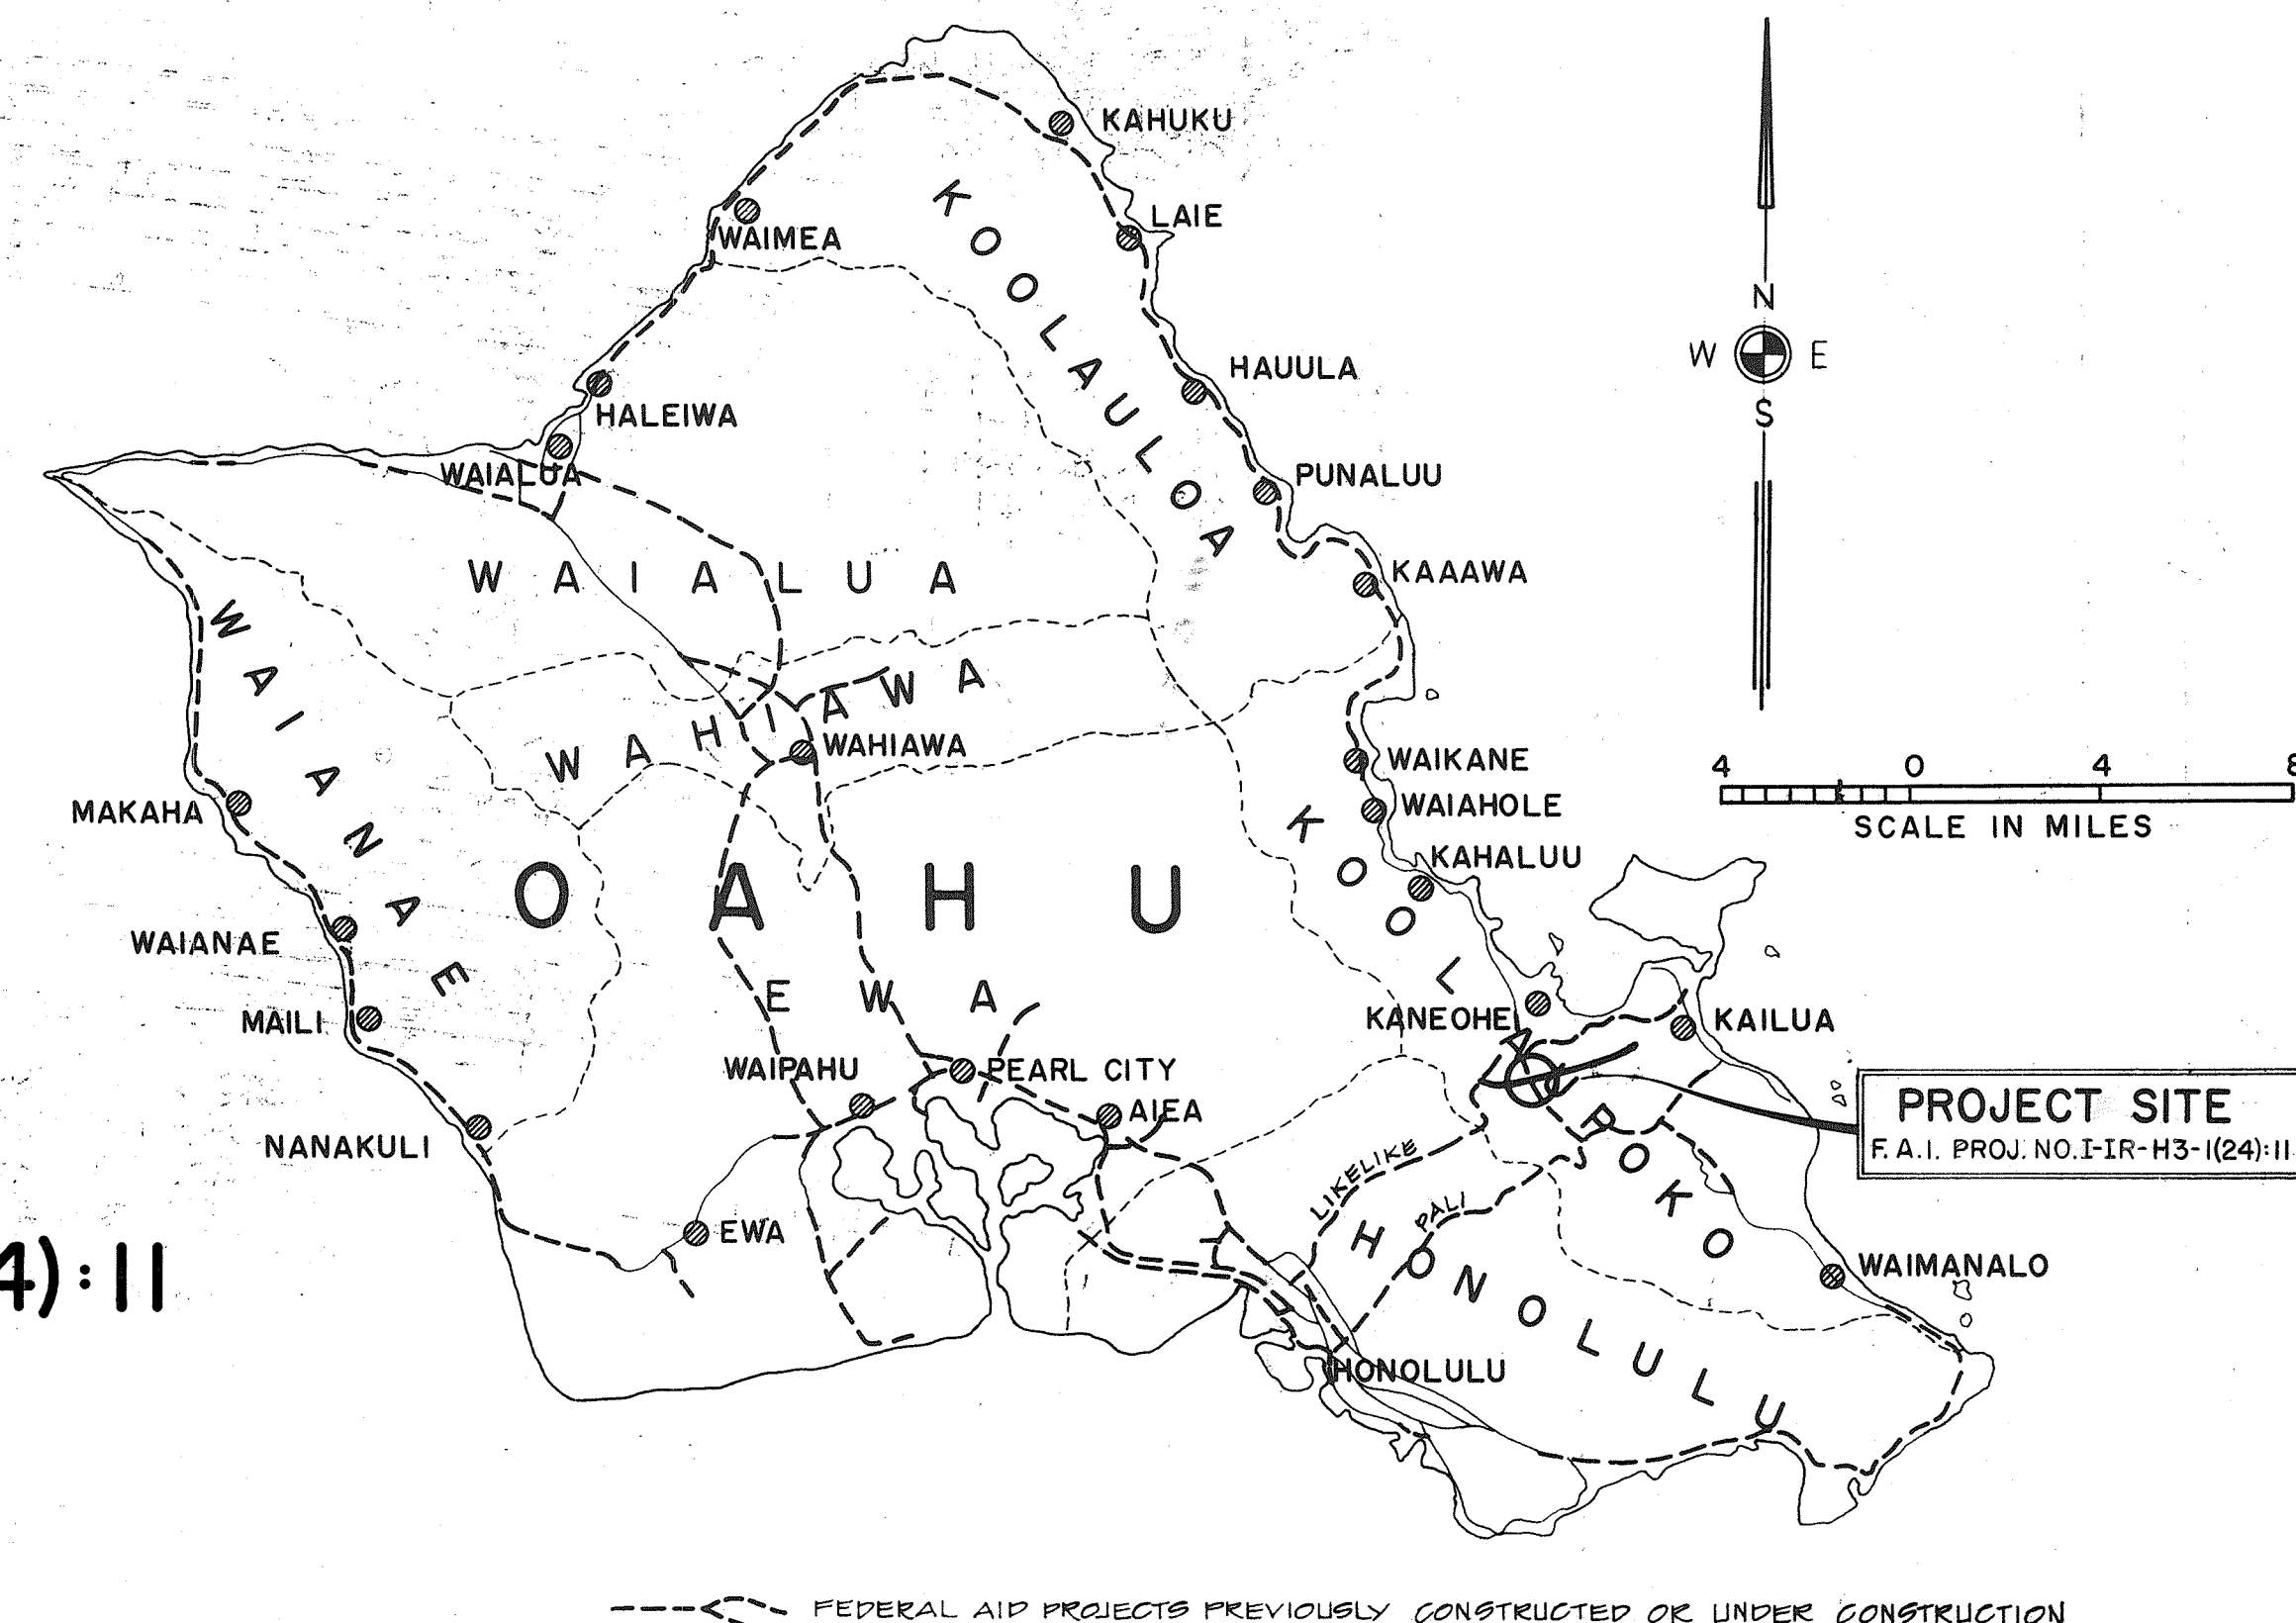

DISTRICT OF KOOLAUPOKO
ISLAND OF OAHU

SCALES:
PLANS 1" = 50'
PROFILES HORIZ. 1" = 50'
VERT. 1" = 10'
DETAIL ROADWAY PLANS 1" = 50'
CROSS SECTIONS - HORIZ. 1" = 50'
VERT. 1" = 10'

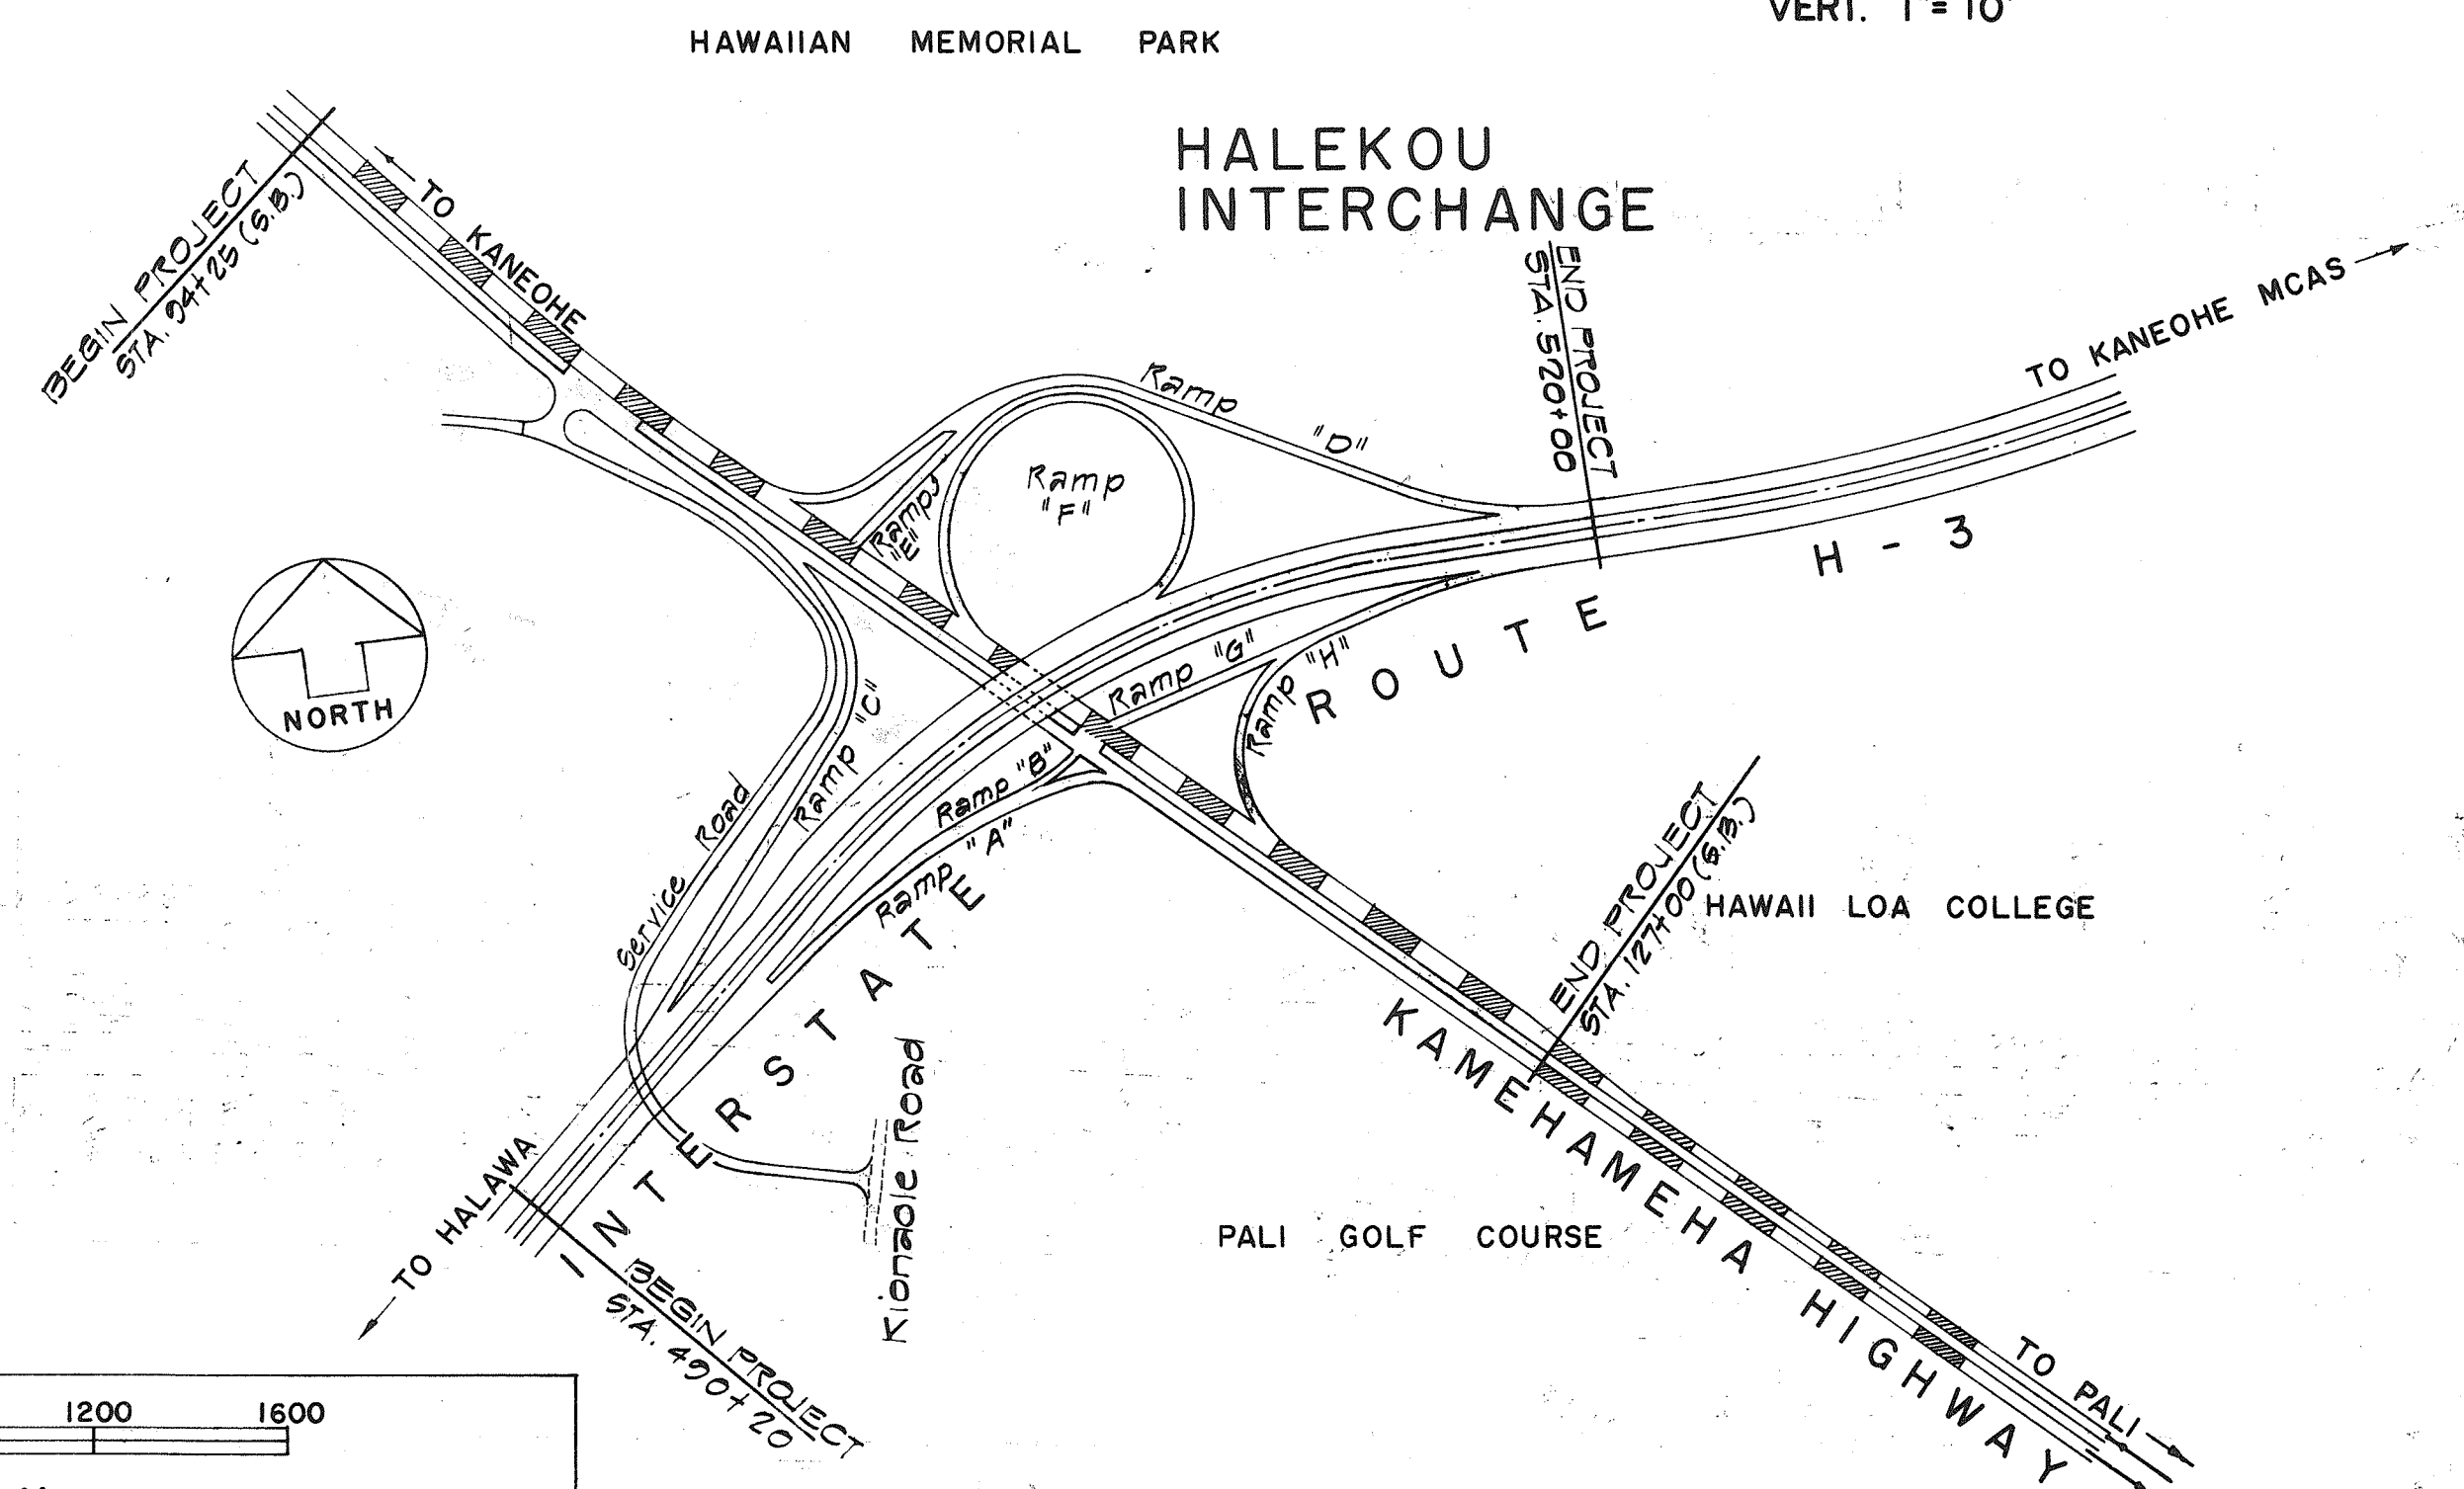

OCT. 1982
DATE
548-4125
PHONE
ALBERT YAMAGUCHI
P. S. & E. BY
ALBERT YAMAGUCHI
REDESIGNED BY

LAYOUT PLAN	
GROSS LENGTH OF PROJECT	0.564 MI.
LENGTH OF STRUCTURES	0.039 MI.
NET LENGTH OF ROADWAY	0.525 MI.

DESIGN DESIGNATION

CURRENT ADT (1983)	20,787
FUTURE ADT (1993)	25,837
DESIGN ADT (2003)	31,776
DHV	2,560
D	67/33
T	2.0%
T ₂₄	3.5%
V	60 MPH

12/22/82
DATE
PROJECT NUMBER AMENDED
PER ADDENDUM NO. 1

DATE
REVISION

DEPARTMENT OF TRANSPORTATION
FEDERAL HIGHWAY ADMINISTRATION
APPROVED:

DIVISION ADMINISTRATOR
11/17/82
DATE

DEPARTMENT OF TRANSPORTATION
STATE OF HAWAII
APPROVED:

DIR. OF TRANSPORTATION
4/8/82
DATE