


INDEX TO DRAWINGS	
SHEET NO.	DESCRIPTION
1	TITLE SHEET
2	STANDARD PLANS SUMMARY
3-4	NOTES
5	ABBREVIATIONS
6-8	EXISTING PLAN
9-10	GENERAL PLAN
11	TYPICAL ROADWAY SECTIONS
12-13	PLAN
14	PIERS, ABUTMENTS, & CURVES SUMMARY
15-21	SUPERELEVATION DIAGRAMS
22-24	PROFILES
25	DEMOLITION PLAN
26	GRADING PLAN
27	JOINTING PLAN
28	P.C.C. PAVEMENT JOINT DETAILS
29	DRAINAGE SUMMARY
30-31	DRAINAGE PLAN
32-33	DRAINAGE PROFILES
34	GRP DRAINAGE & SLOPE PROTECTION & MISC. DETAIL
35	DRAINAGE INLET/OUTLET & PIPE ANCHOR DETAIL
36	MODIFIED TYPE "C1" CATCH BASIN
37	ENERGY DISSIPATOR
38	EROSION CONTROL
39-41	TIE - BACK WALL
42-230S-1	BRIDGE PLANS & DETAILS
231-262	BORING LOGS
263-271	ELECTRICAL PLANS & DETAILS
272-274	GROUND SYSTEM MODIFICATION PLANS
274RS-1 - 274RS-12	CROSS SECTIONS

ADDED PLAN SHEETS: 271 S1 CONDUIT & PULLBOX PLACEMENT DETAILS
TOTAL SHEETS AFTER ADDITION : 289 SHEETS

STATE OF HAWAII
DEPARTMENT OF TRANSPORTATION
HIGHWAYS DIVISION
HONOLULU, HAWAII

PLANS FOR
CONSTRUCTION OF A PORTION OF
INTERSTATE ROUTE H-3
WINDWARD VIADUCT
FEDERAL AID INTERSTATE PROJECT NO. I-H3-I (57)
AND
FEDERAL AID INTERSTATE PROJECT NO. I-H3-I (58)
DISTRICT OF KOOLAUPOKO
ISLAND OF OAHU

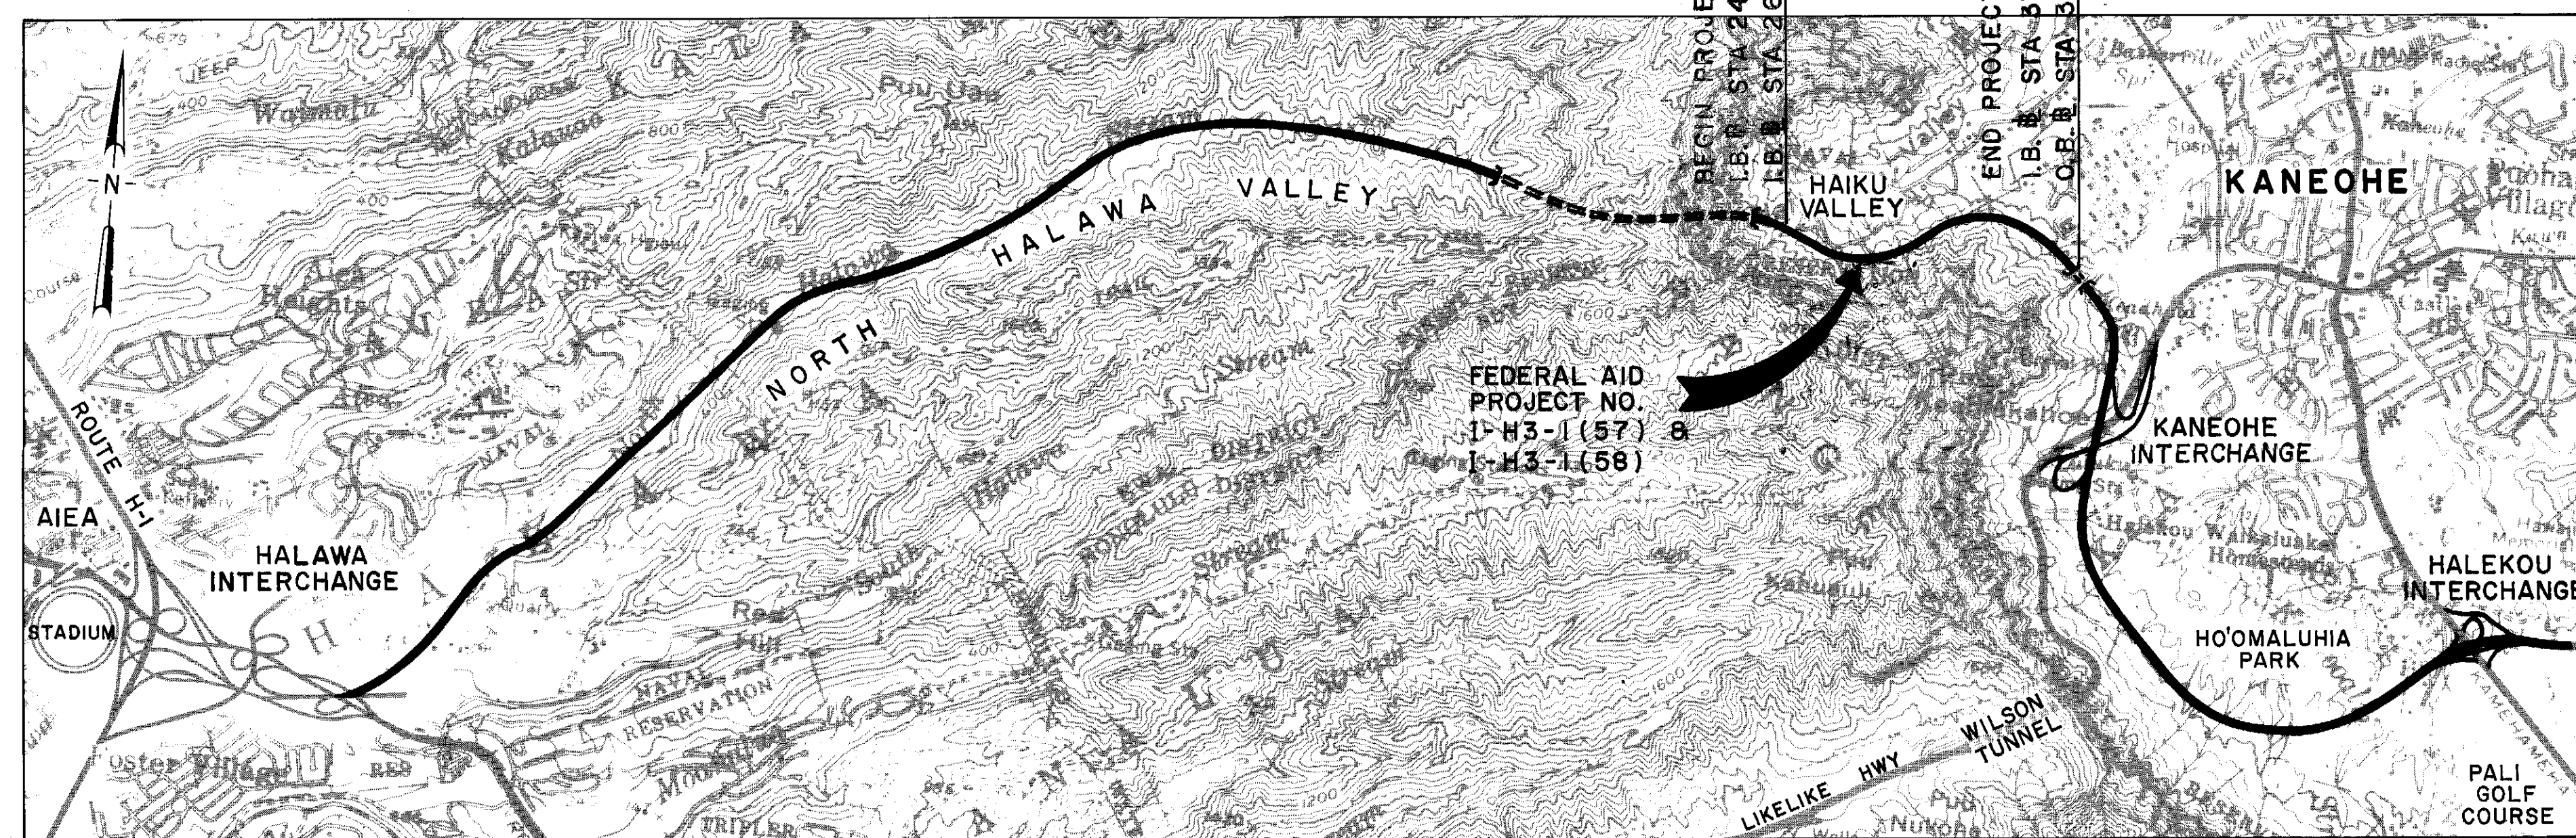


DESIGN CLASSIFICATION

ADT (2000) INBOUND 19,520
ADT (2000) OUTBOUND 19,910
DHV 9.5 %
D 76/24
T 2.5 %
V 50 MPH

LAYOUT PLAN

GROSS LENGTH OF PROJECT 1.35 MI.
BRIDGES OVER 20.00' SPAN 1.25 MI.
NET LENGTH OF ROADWAY 0.10 MI.

1/2 0 1/2
SCALE IN MILES

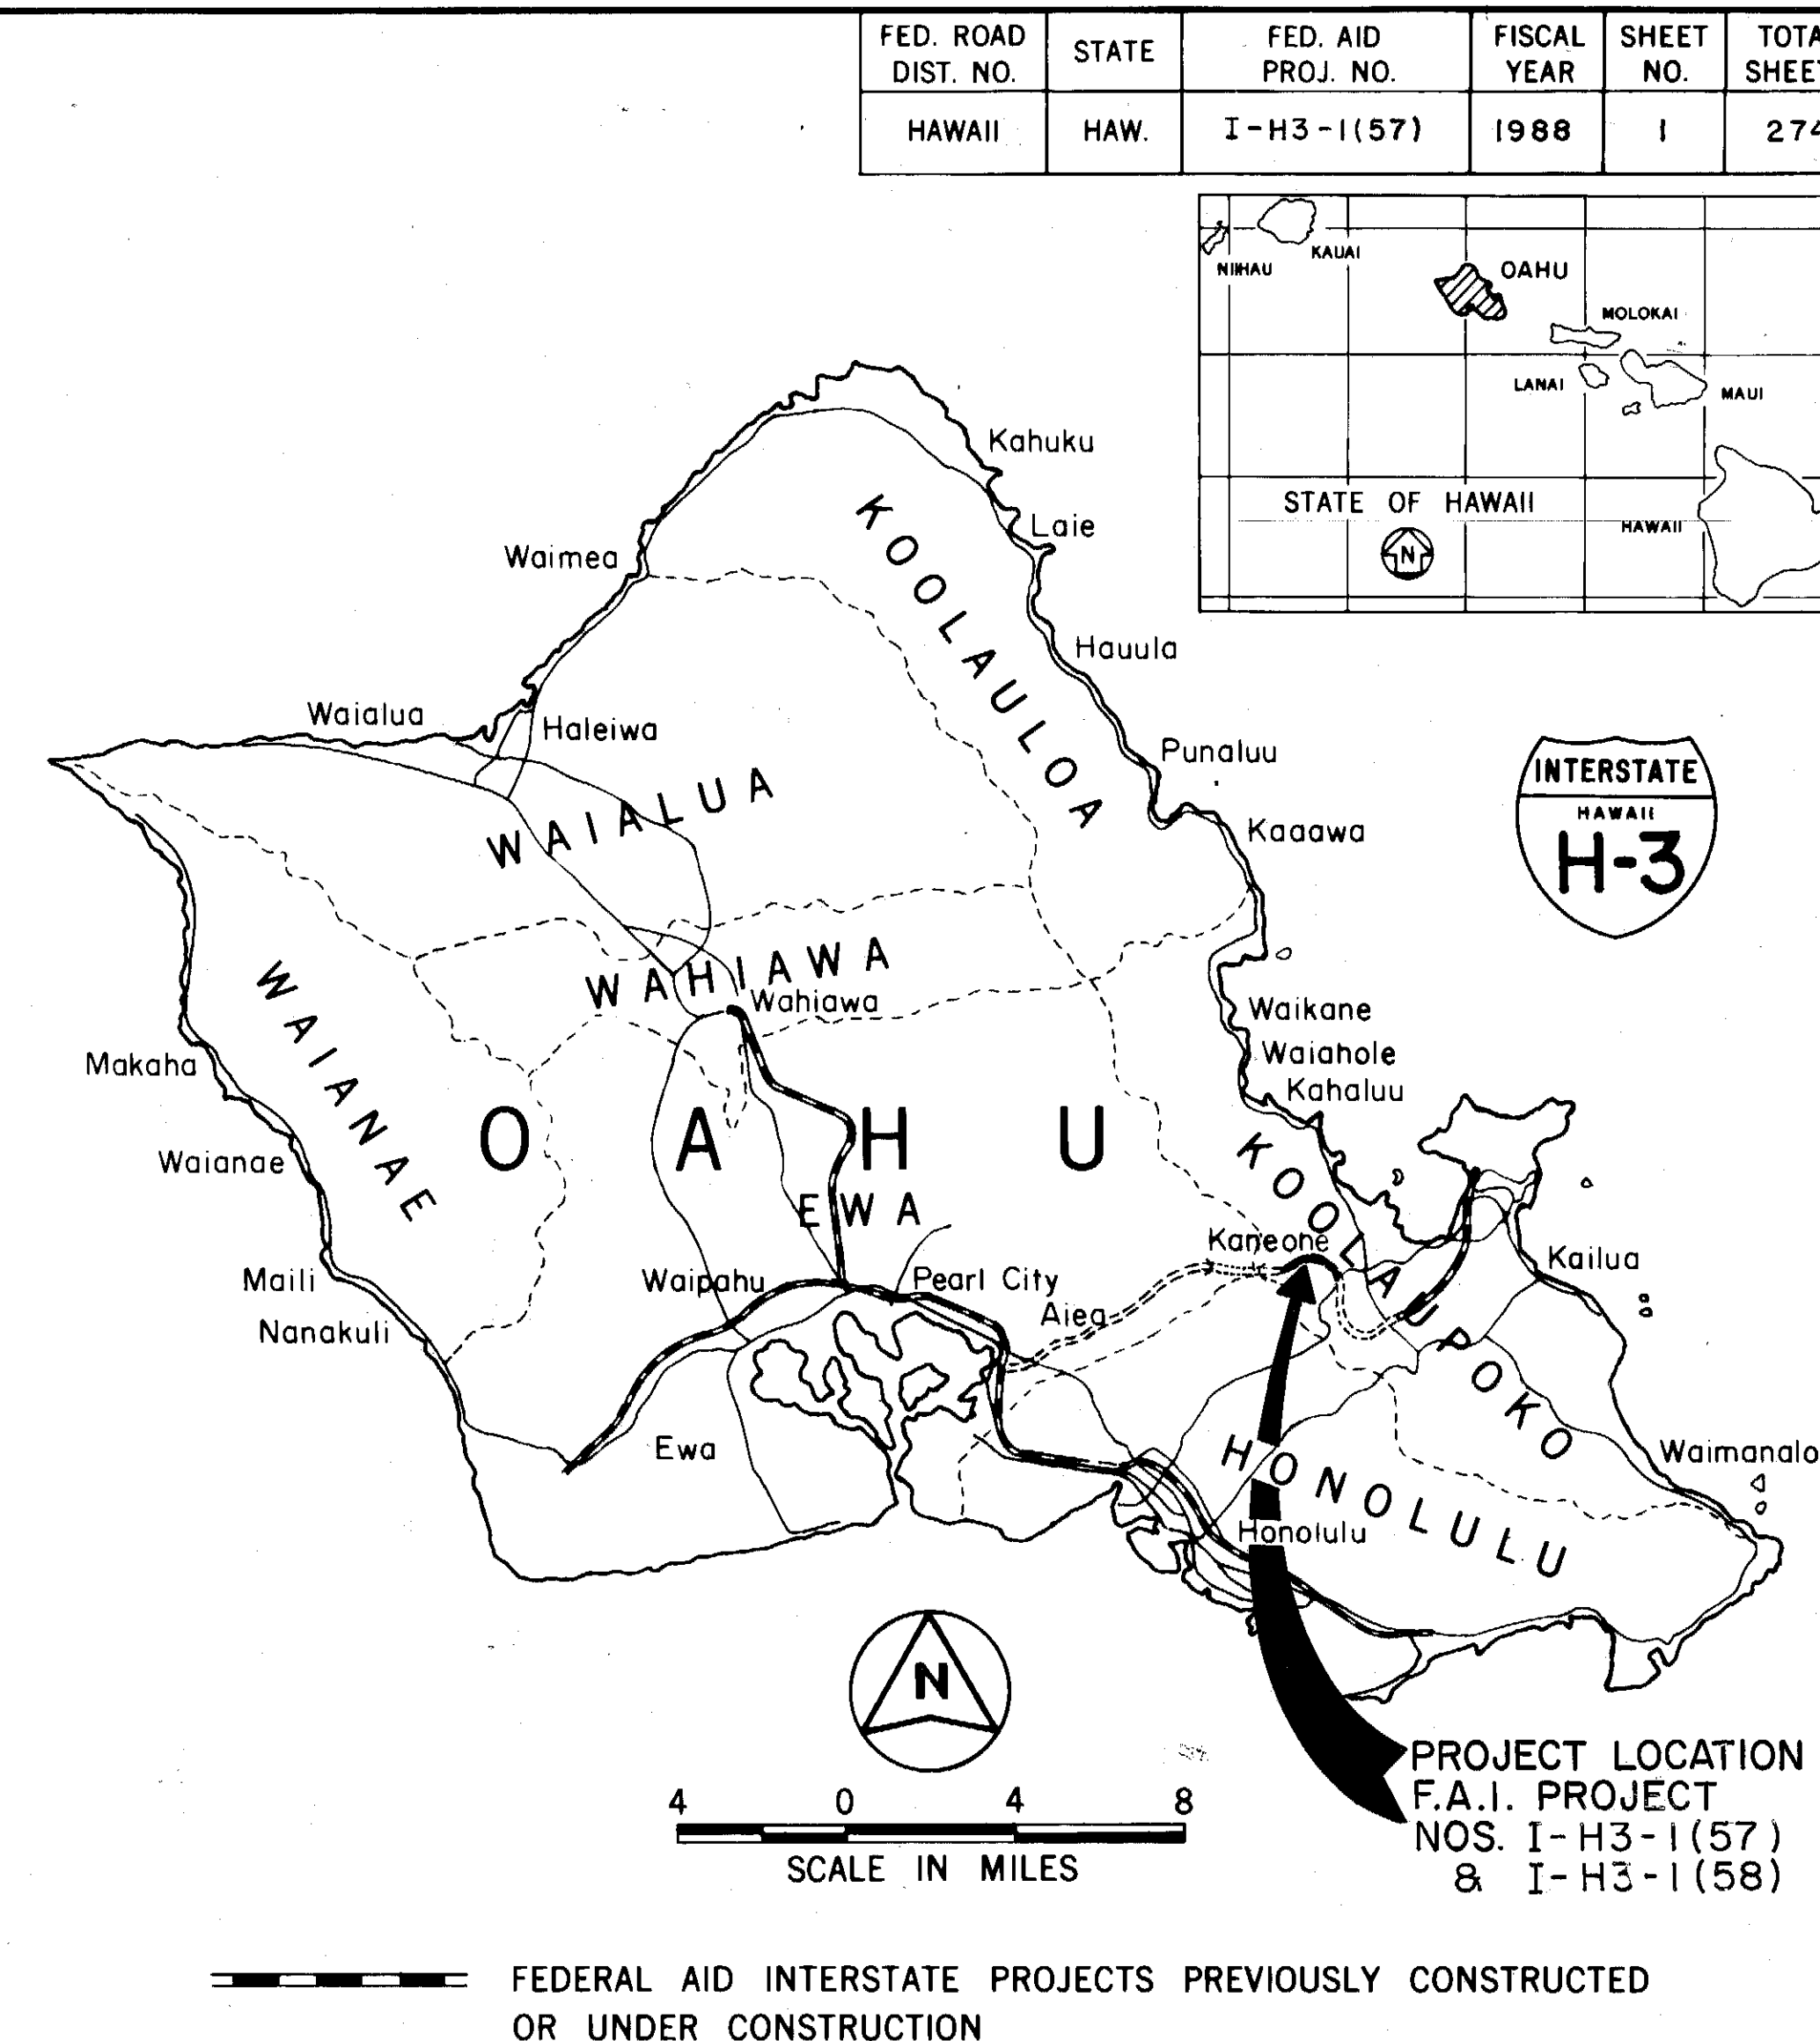

Handwritten signature and date: 2/1/85

WILSON OKAMOTO & ASSOCIATE
DESIGNED BY
TIT MUN CHUN
P. S. & E. BY
548-7531
PHONE
5/89
DATE

DEPARTMENT OF TRANSPORTATION
FEDERAL HIGHWAY AID
APPROVED: *Handwritten signature*
DIVISION ADMINISTRATOR
DATE: 1-64

DEPARTMENT OF TRANSPORTATION
STATE OF HAWAII
APPROVED: *Handwritten signature*
DIR. OF TRANSPORTATION
DATE: 12/20/85

C.O. ADD 1

FED. ROAD DIST. NO.	STATE	FED. AID PROJ. NO.	FISCAL YEAR	SHEET NO.	TOTAL SHEETS
HAWAII	HAW.	I-H3-1 (57)	1988		

STATE OF HAWAII

VECP #2

PLANS FOR

CONSTRUCTION OF A PORTION OF

INTERSTATE ROUTE H-3

WINDWARD VIADUCT



FEDERAL AID INTERSTATE PROJECT NO. I-H3-1 (57)

AND

FEDERAL AID INTERSTATE PROJECT NO. I-H3-1 (58)

DISTRICT OF KOOLAUPOKO

ISLAND OF OAHU

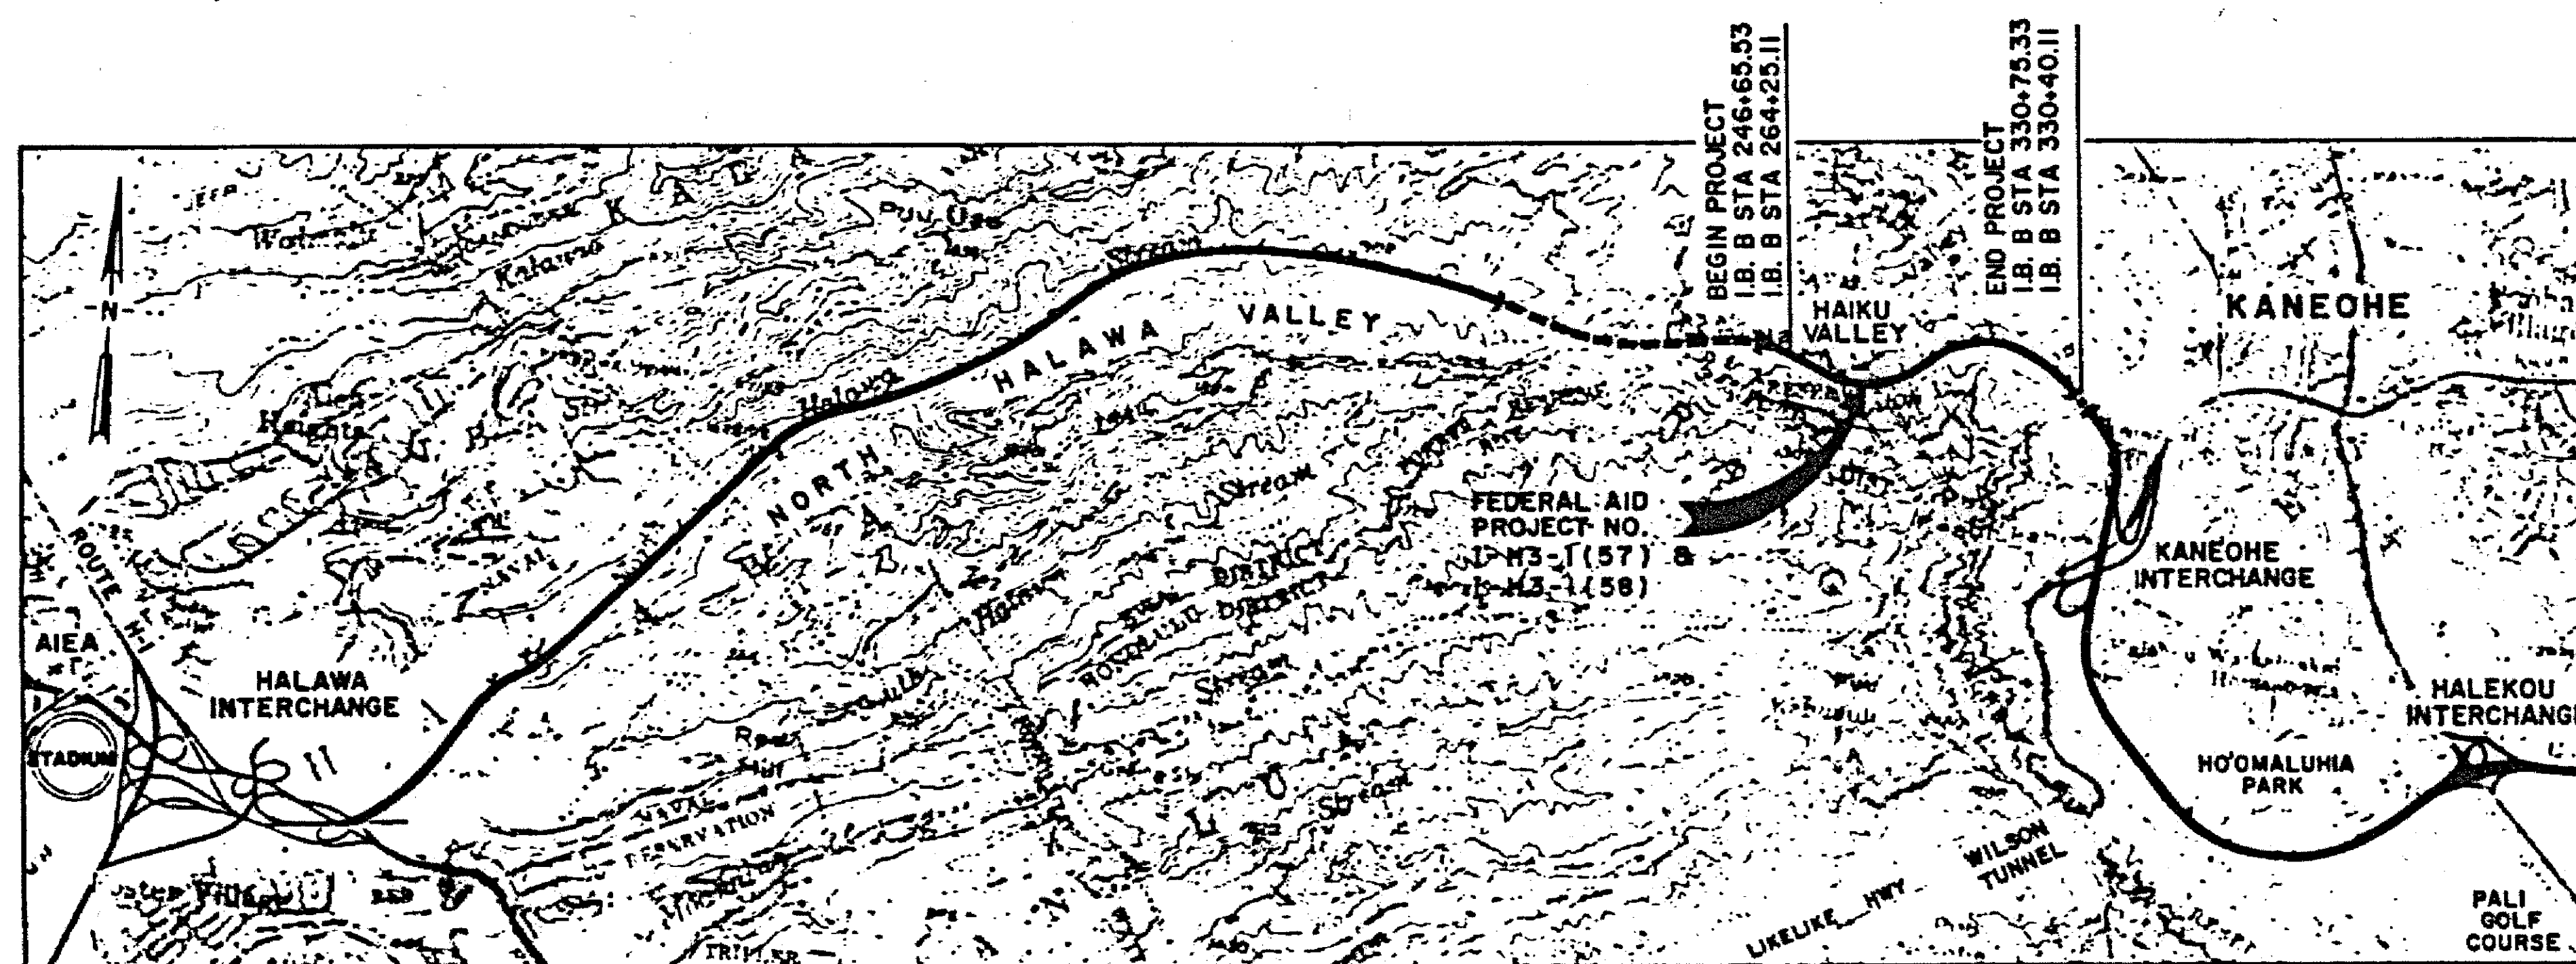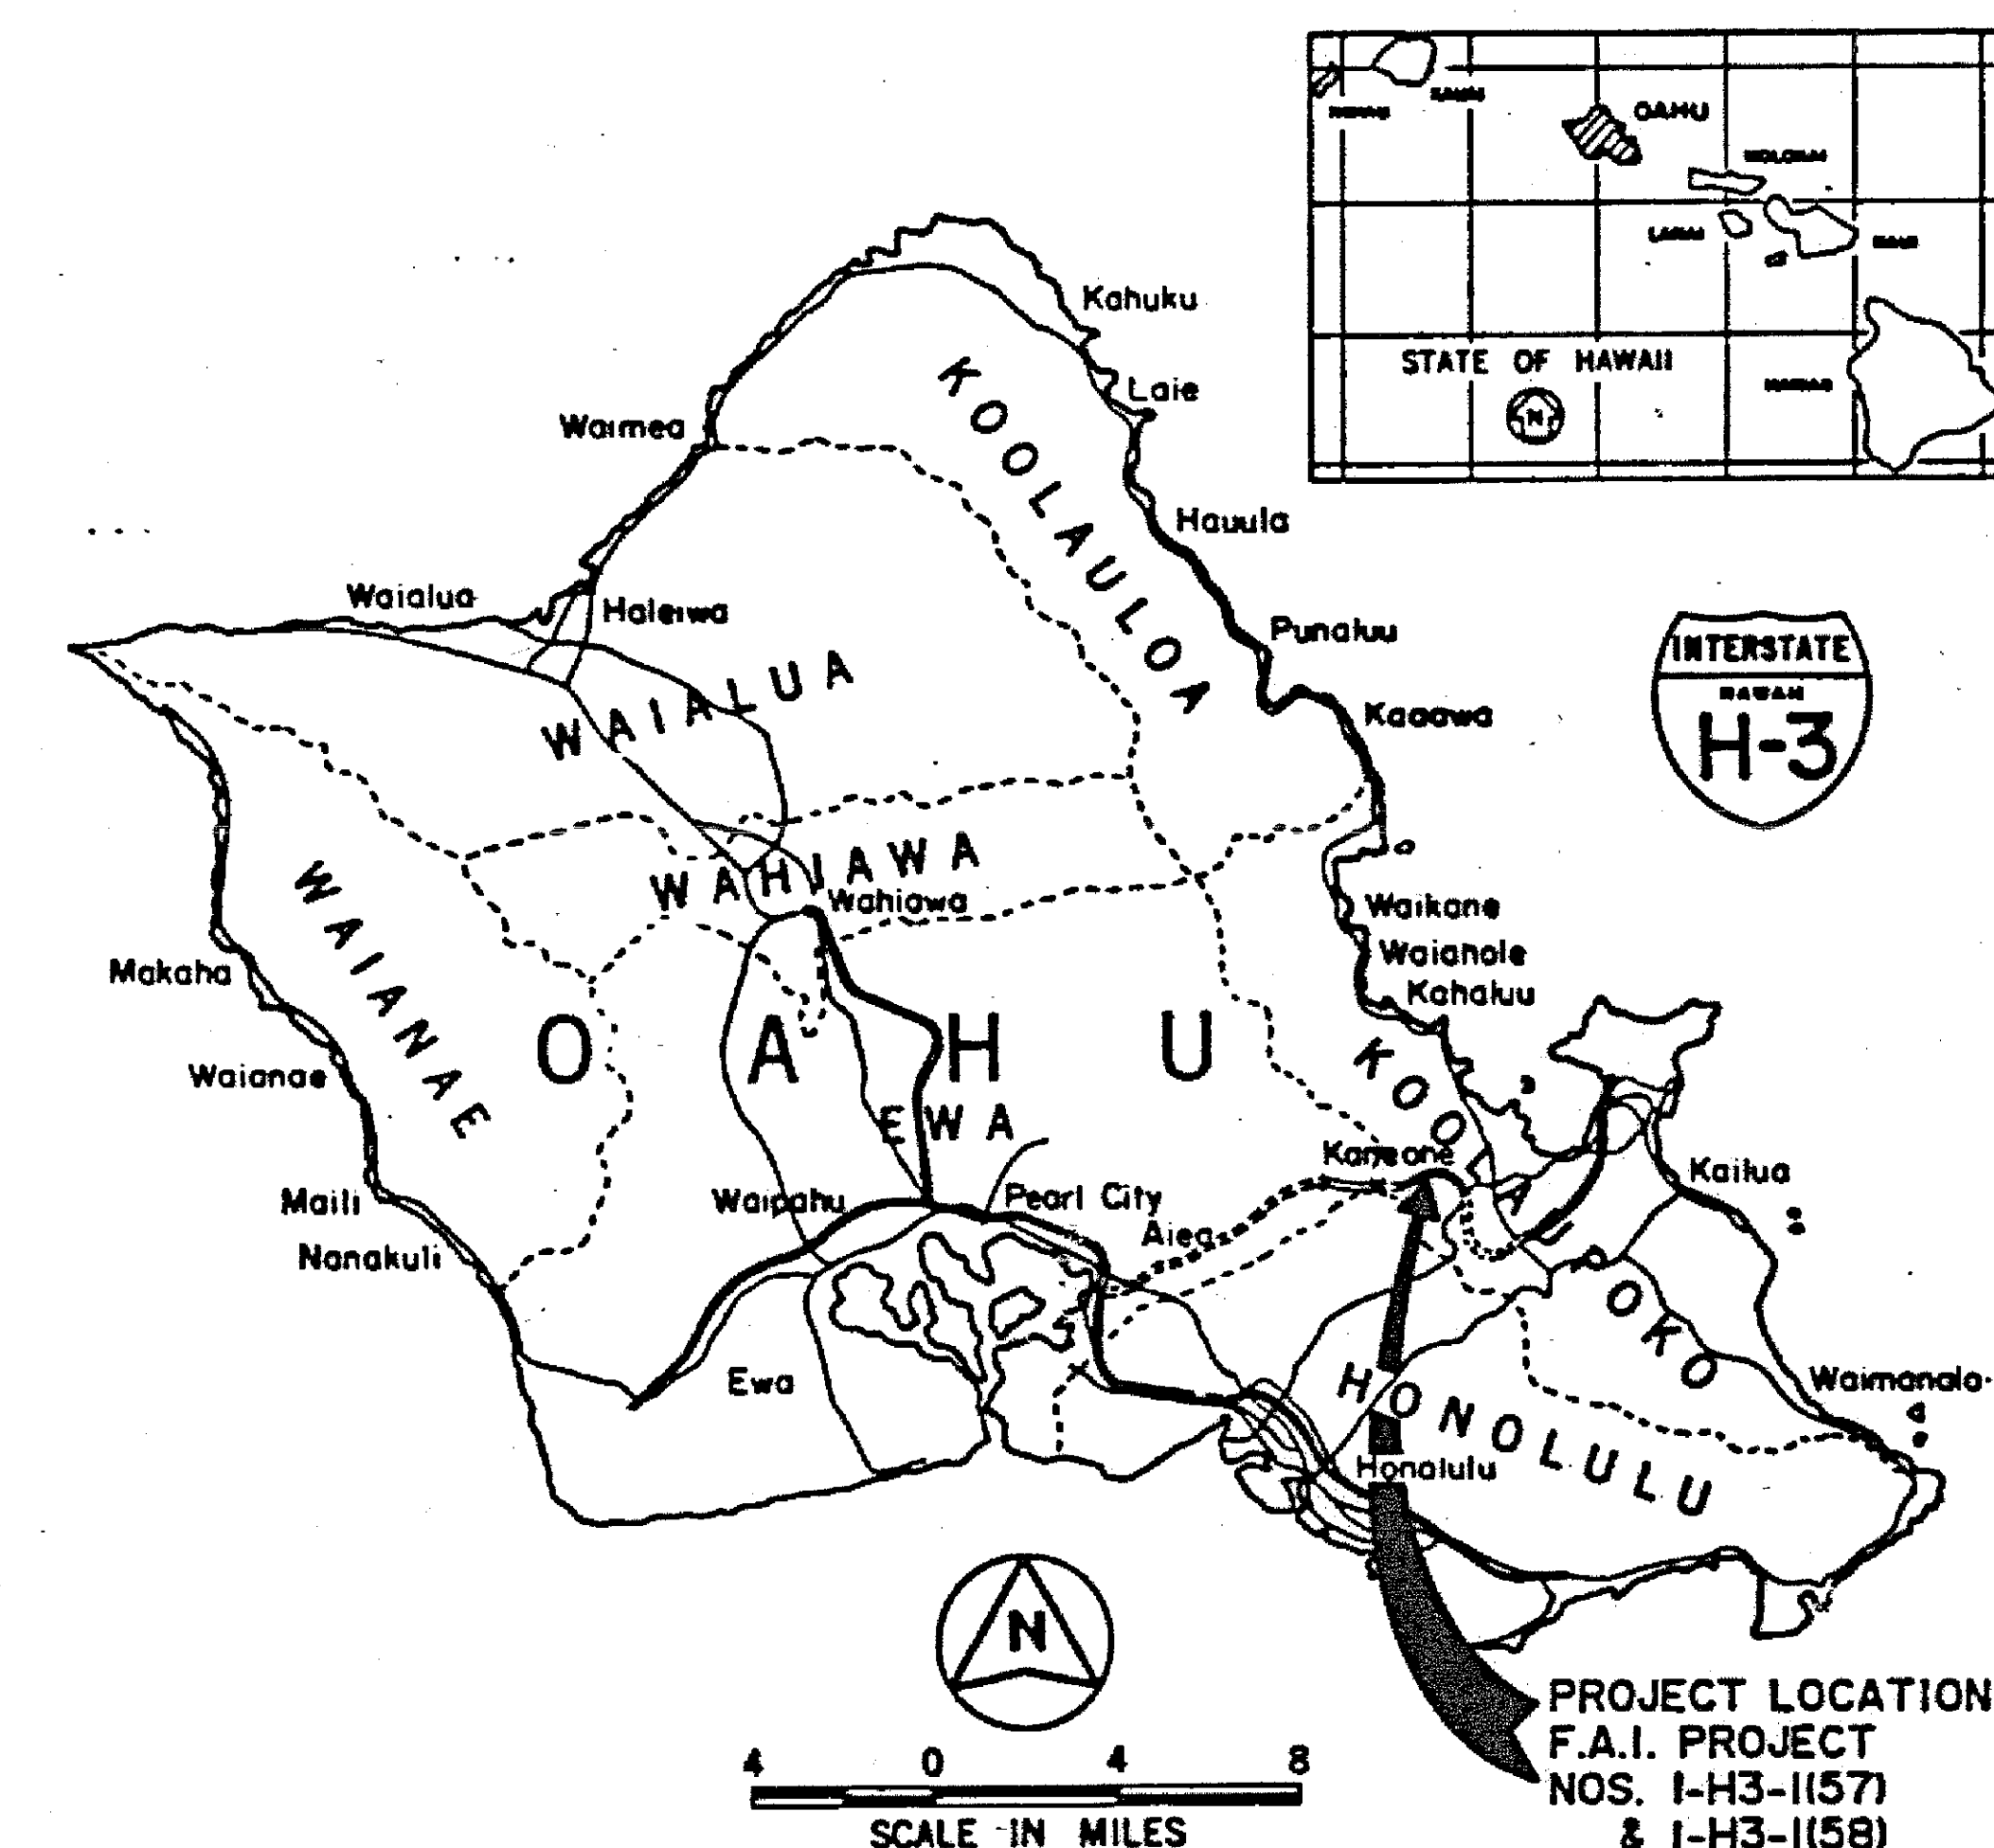

LAYOUT PLAN

GROSS LENGTH OF PROJECT1.35 MI.
BRIDGES OVER 20.00' SPAN1.25 MI.
NET LENGTH OF ROADWAY.....0.10 MI.

— FEDERAL AID INTERSTATE PROJECTS PREVIOUSLY CONSTRUCTED OR UNDER CONSTRUCTION

DATE	
DESIGNED BY	
DRAWN BY	
CHECKED BY	
NOTED BY	
APPROVED BY	

STATE OF HAWAII DEPARTMENT OF TRANSPORTATION HIGHWAYS DIVISION	
INTERSTATE ROUTE H-3 F.A.I. PROJECT No. I-H3-1 (57) F.A.I. PROJECT No. I-H3-1 (58)	
DATE	REVISION
J. MULLER INTERNATIONAL	E Libby Engineers
SCALE : AS NOTED DATE : JUN. 1990	
SHEET NO. OF 280 SHEETS	