
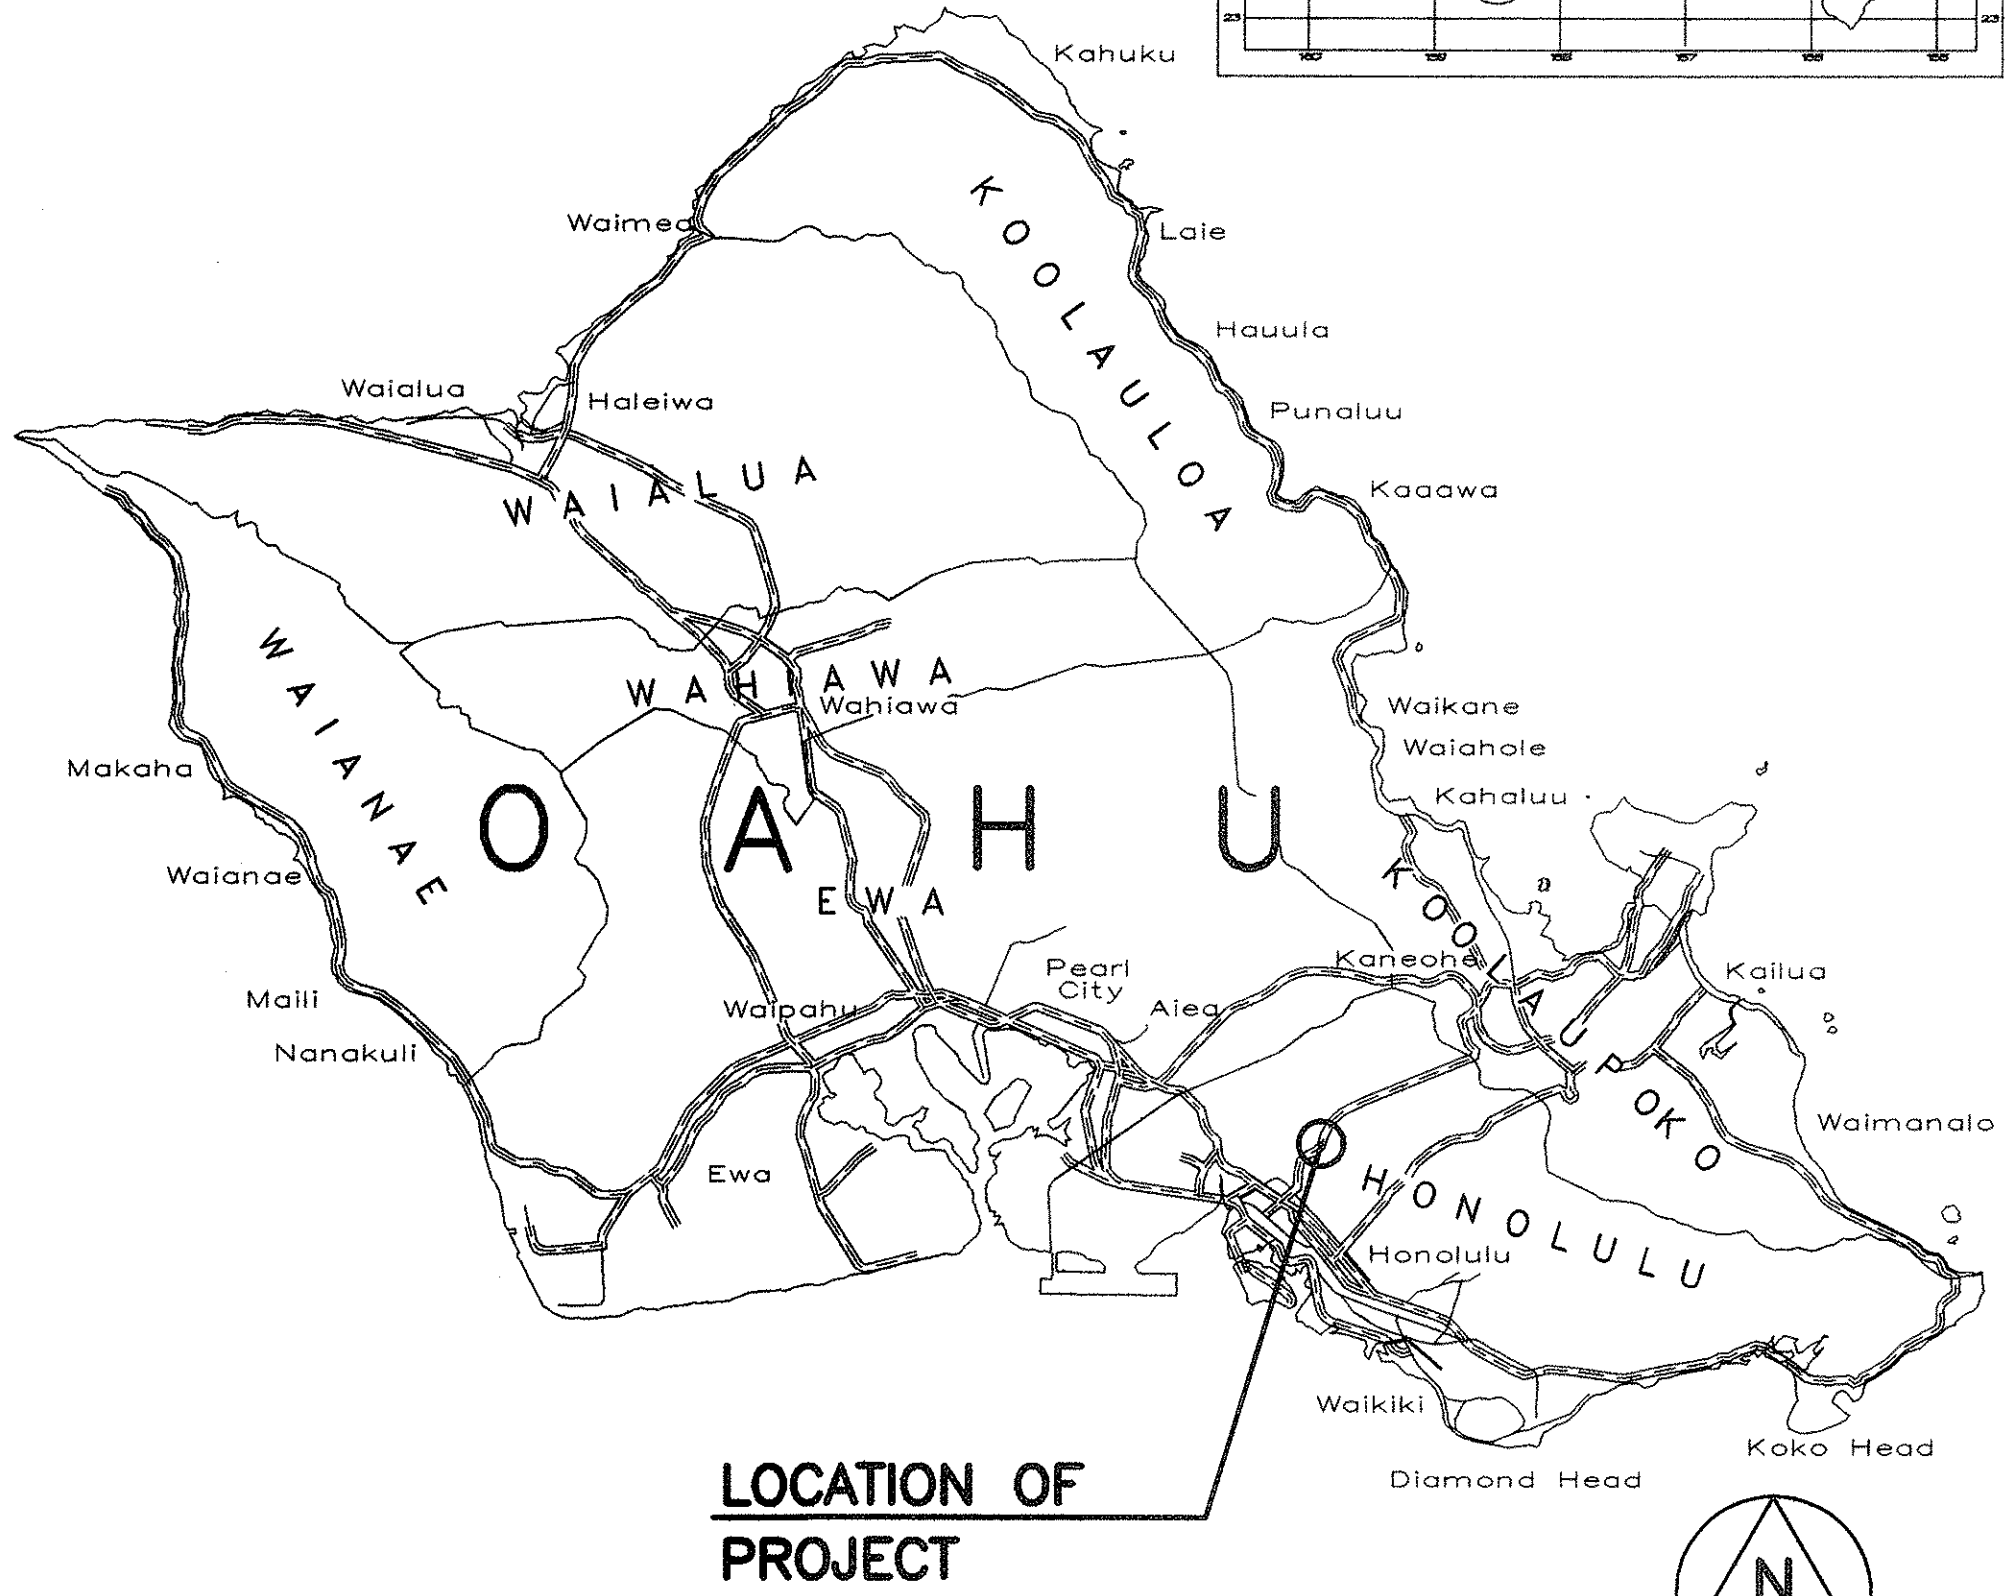



INDEX TO DRAWINGS	
SHEET NO.	DESCRIPTION
1	TITLE SHEET
2	A-1 WORK SCOPE
3	A-2 RENOVATE EXISTING STORAGE ROOM 'A'
4	A-3 STORAGE ROOM 'A' DETAILS
5	A-4 STORAGE ROOM 'A' DETAILS
6	A-5 CONSTRUCT NEW STORAGE ROOM 'B'
7	A-6 STORAGE ROOM 'B' DETAILS
8	A-7 STORAGE ROOM 'B' DETAILS
9	A-8 RENOVATE EXISTING MATERIAL TESTING LABORATORY
10	A-9 MATERIAL TESTING LABORATORY DETAILS
11	A-10 MATERIAL TESTING LABORATORY DETAILS
12	M-1 PARTIAL FLOOR PLAN-MECH. DETAILS
13	M-2 GENERAL NOTES, LEGEND & SCHEDULE
14	E-1 ELECTRICAL PLAN

STATE OF HAWAII
DEPARTMENT OF TRANSPORTATION
HIGHWAYS DIVISION
HONOLULU, HAWAII
"AS-BUILT"
PLANS FOR
MATERIALS TESTING LABORATORY
FACILITY IMPROVEMENTS
PROJECT NO. HWY-O-02-98M
2530 LIKELIKE HIGHWAY
HONOLULU, HAWAII
TAX MAP KEY 1-4-22:14
DISTRICT OF HONOLULU
ISLAND OF OAHU

DIST. NO.	STATE	PROJ. NO.	FISCAL YEAR	SHEET NO.	TOTAL SHEETS
HAWAII	HAW.	HWY-O-02-98M	1998	1	14

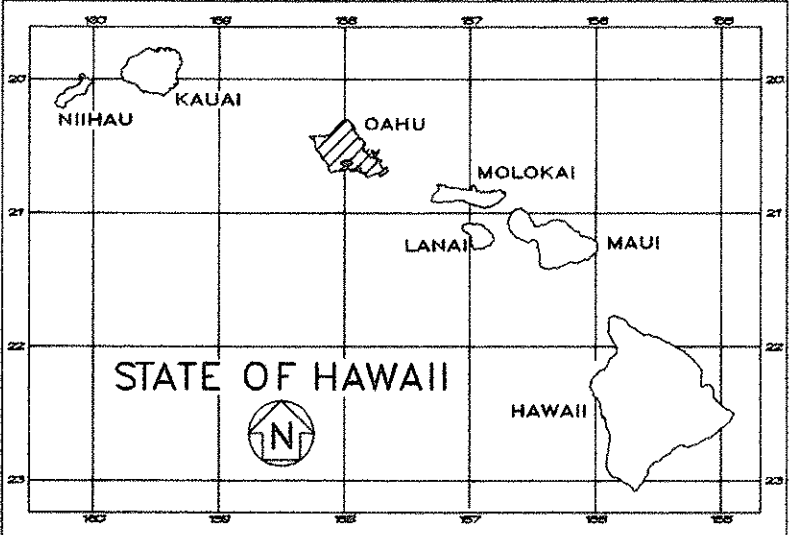

LOCATION OF PROJECT

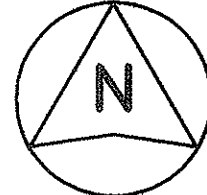

SCALE IN MILES


FEDERAL AID PROJECTS PREVIOUSLY CONSTRUCTED OR UNDER CONSTRUCTION

MILE POST 2.92 TO MILE POST 2.94

CHANGES MADE DURING CONSTRUCTION HAVE BEEN INCORPORATED ON THE PLANS EXCEPT CHANGES IN THE ORIGINAL QUANTITIES. FOR ACTUAL QUANTITIES, REFER TO PROJECT LEDGER AND/OR COMPUTATION BOOK.

RESIDENT ENGINEER

DEPARTMENT OF TRANSPORTATION
STATE OF HAWAII
APPROVED: *Ken M. O'Connell* 6/5/98
DIR. OF TRANSPORTATION DATE

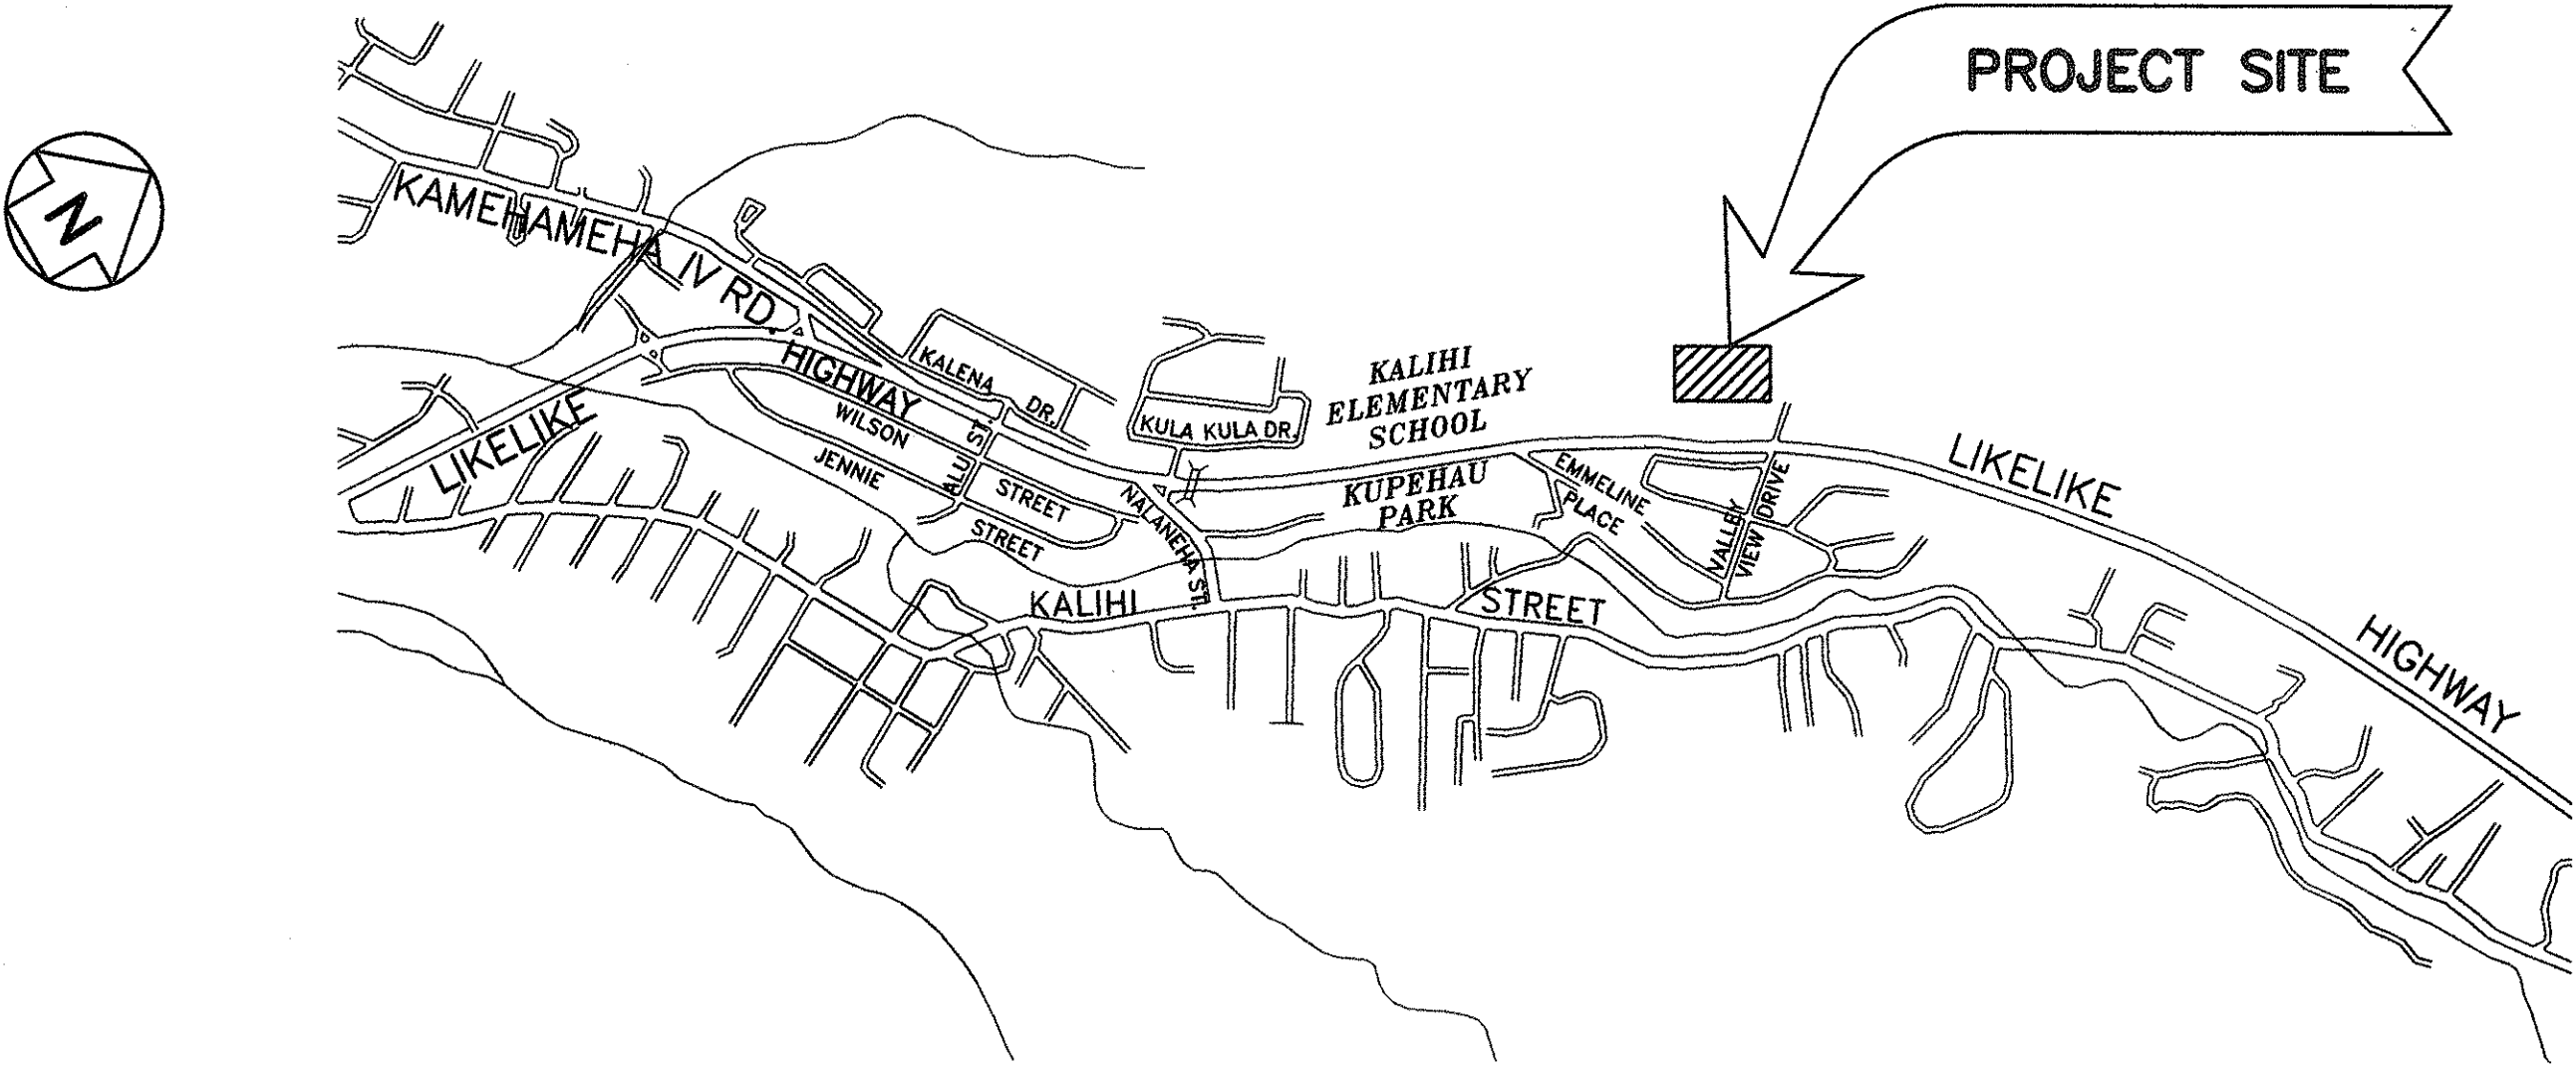

LOCATION PLAN

SCALE IN HUNDRED FEET

LOU CHAN & ASSOC. DESIGNED BY L. CHAN P. S. & E. BY MAY, 1998 DATE 596-7551 PHONE