

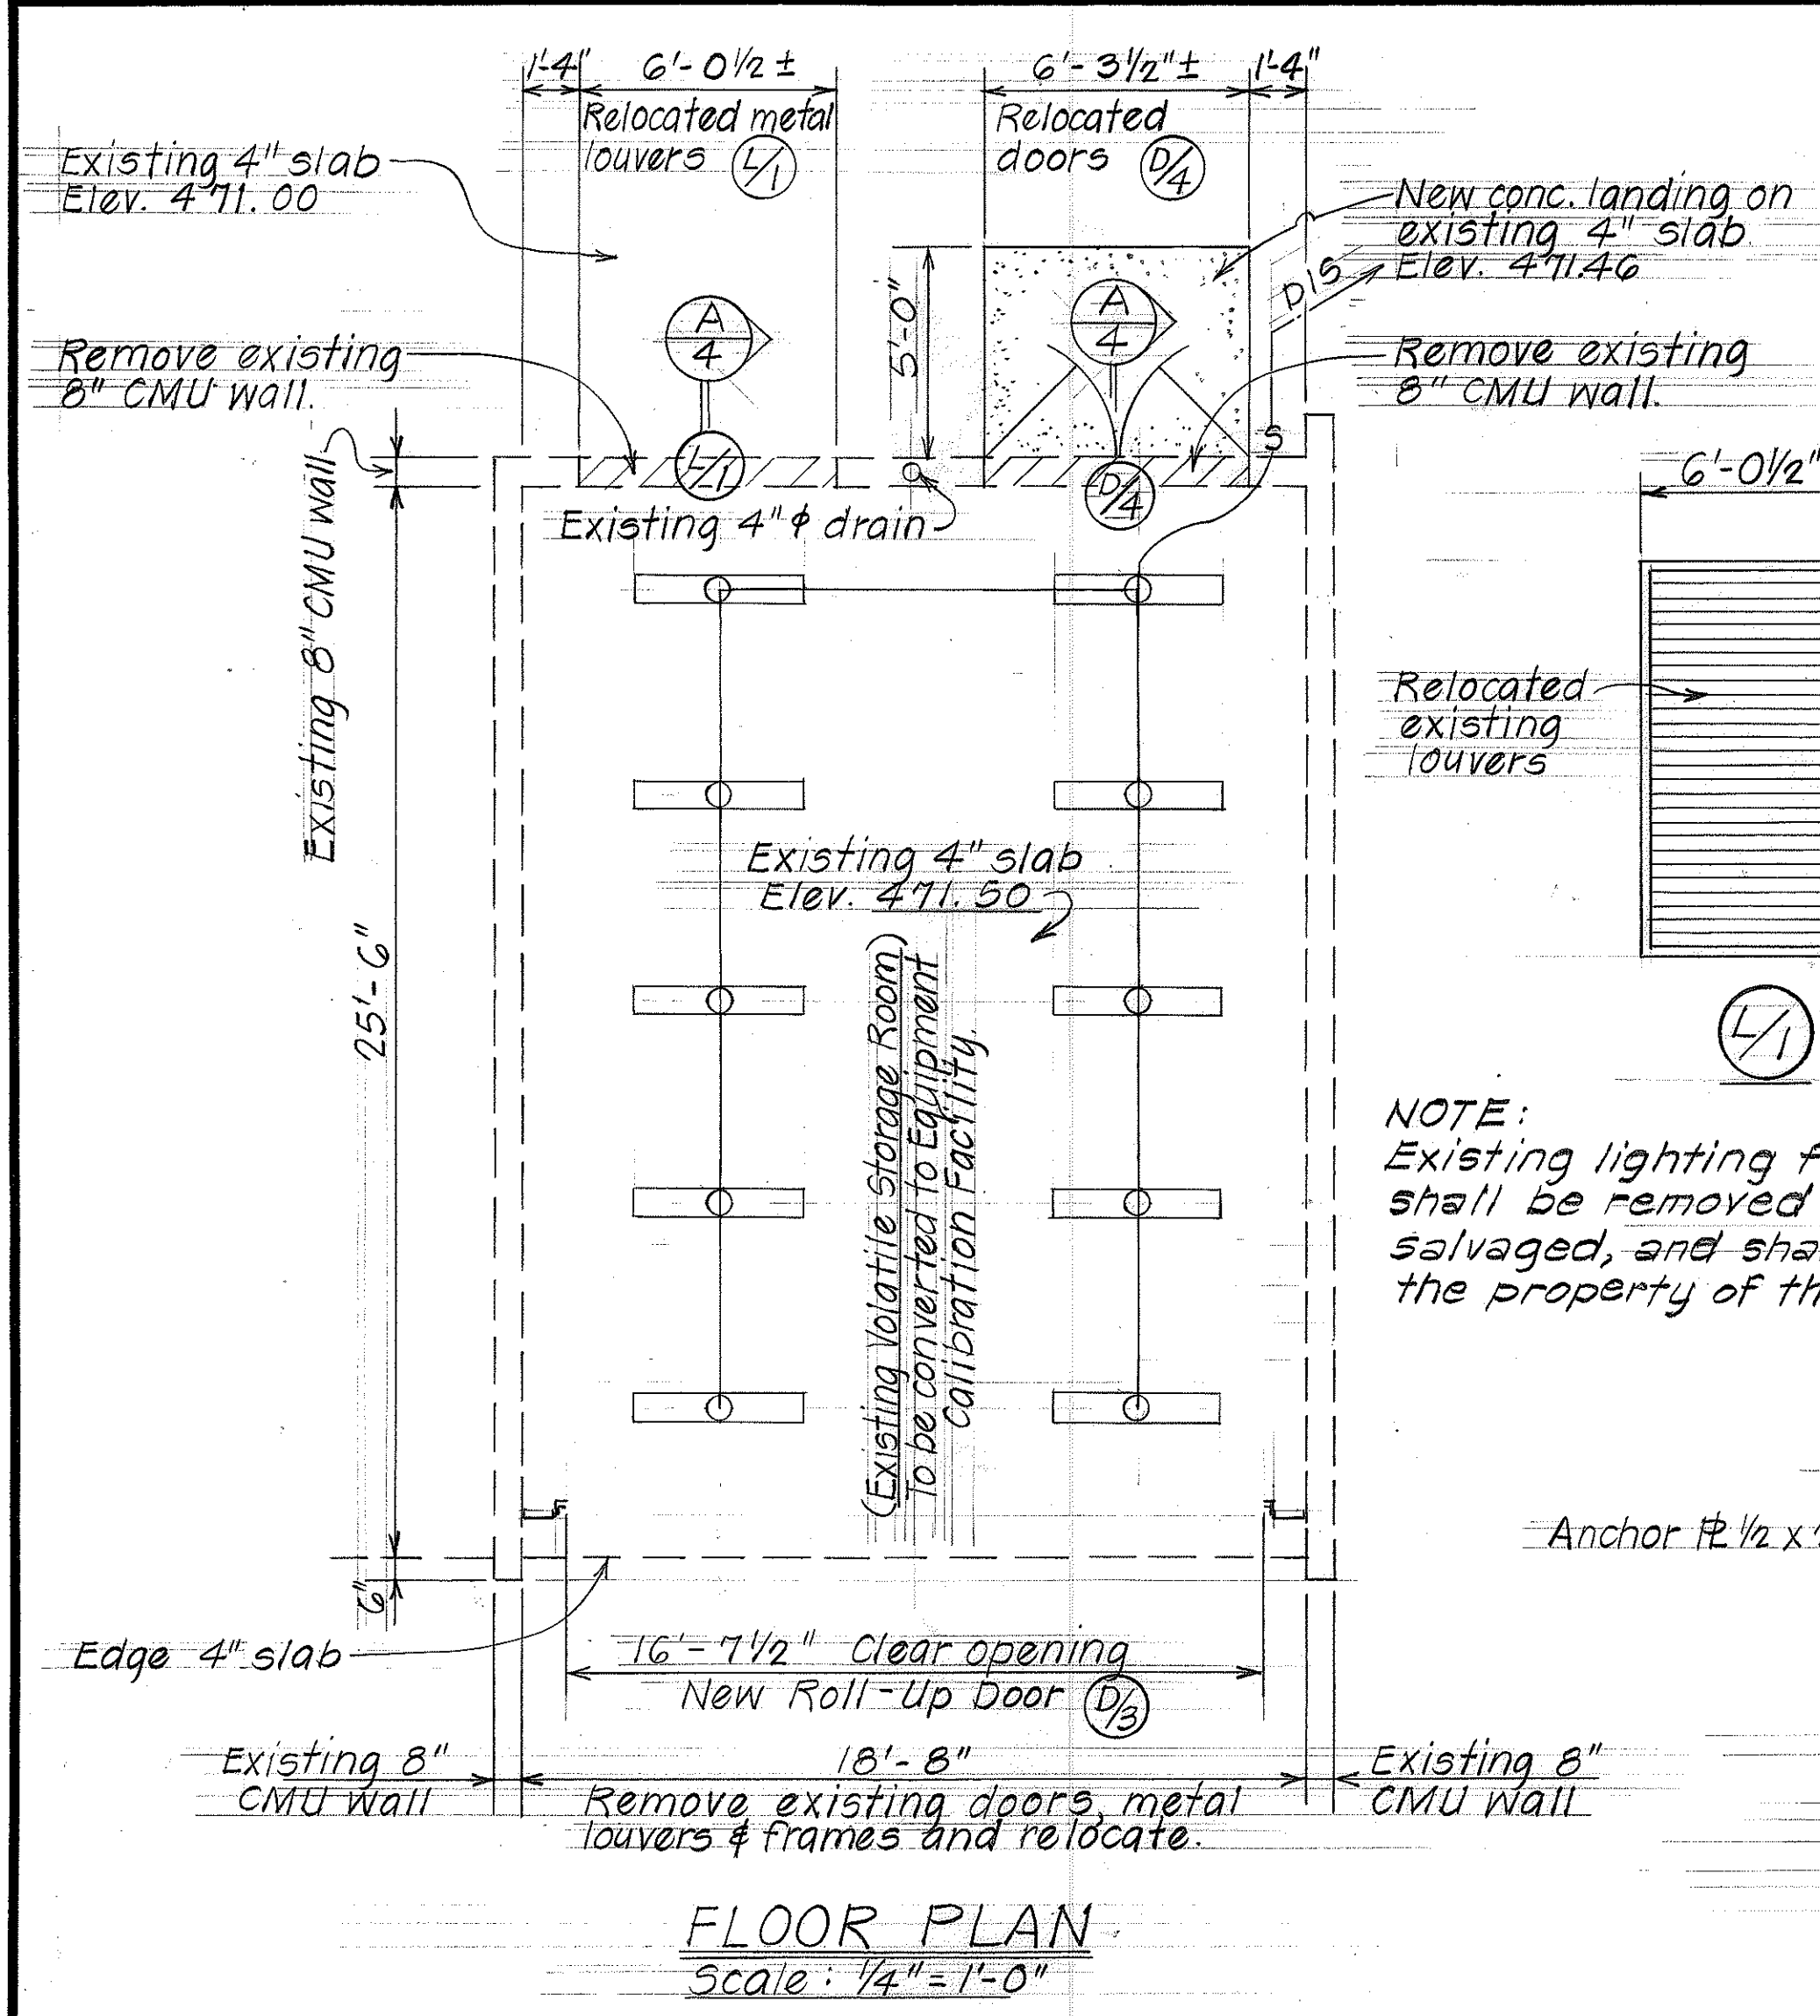
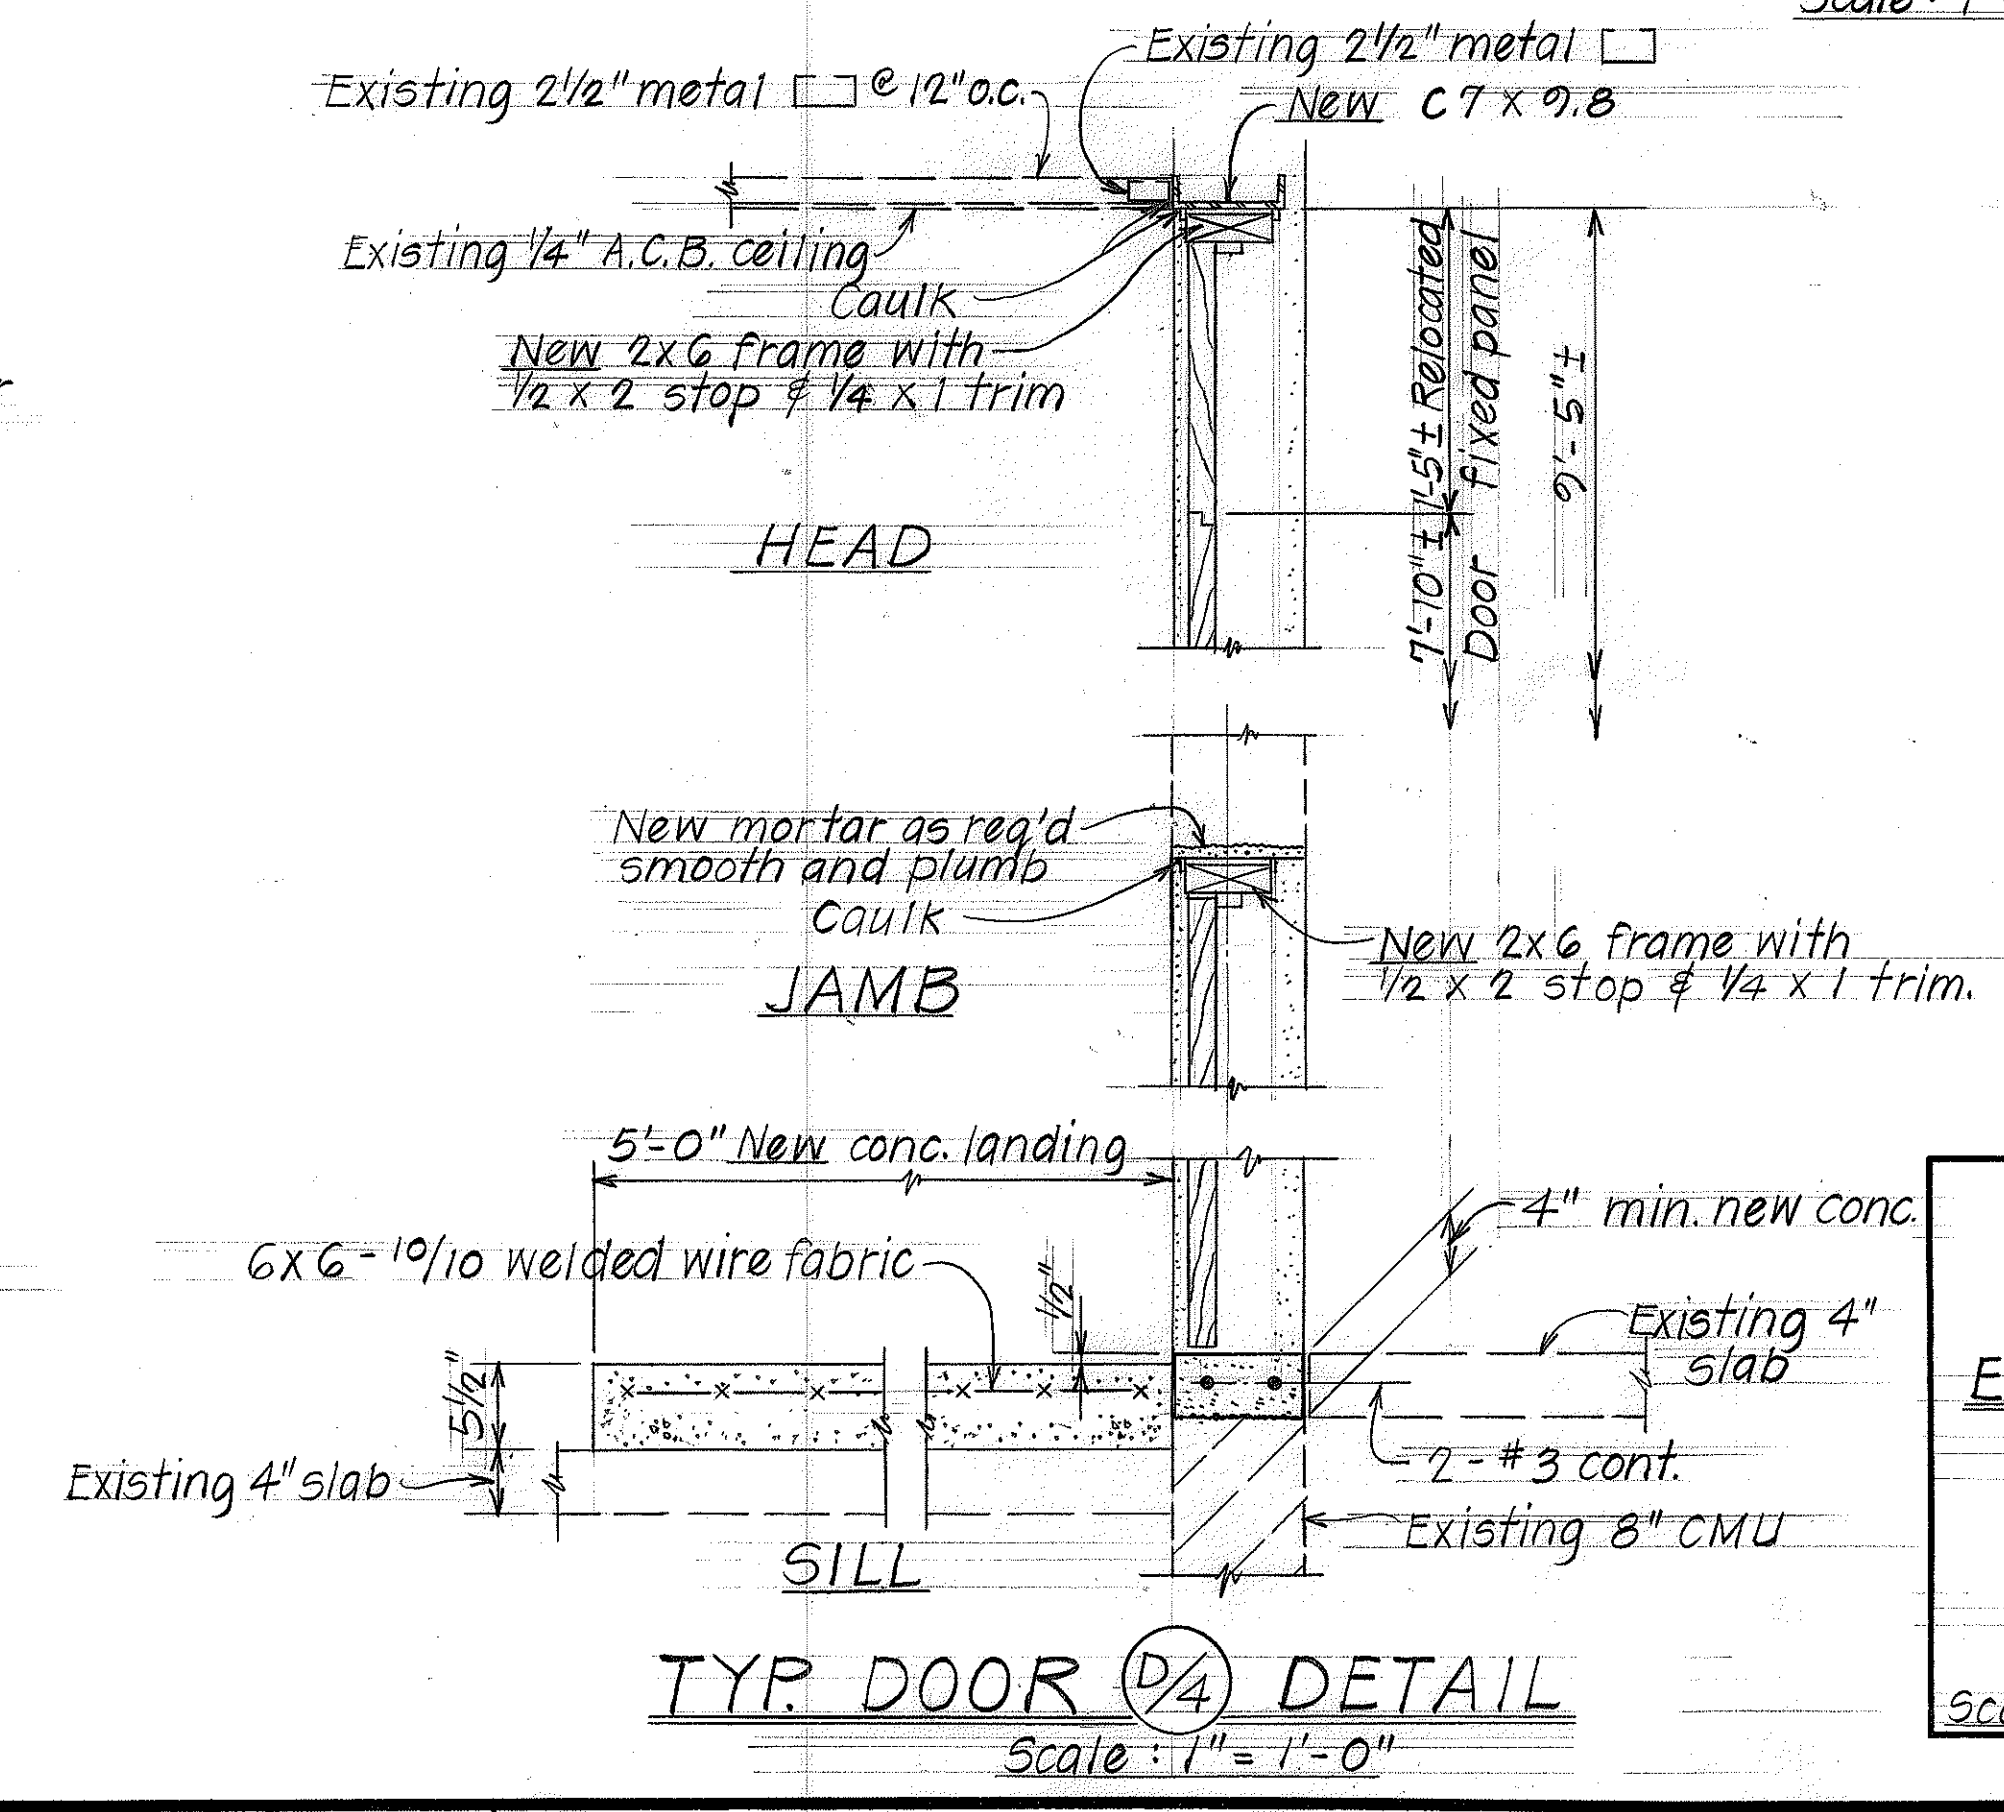
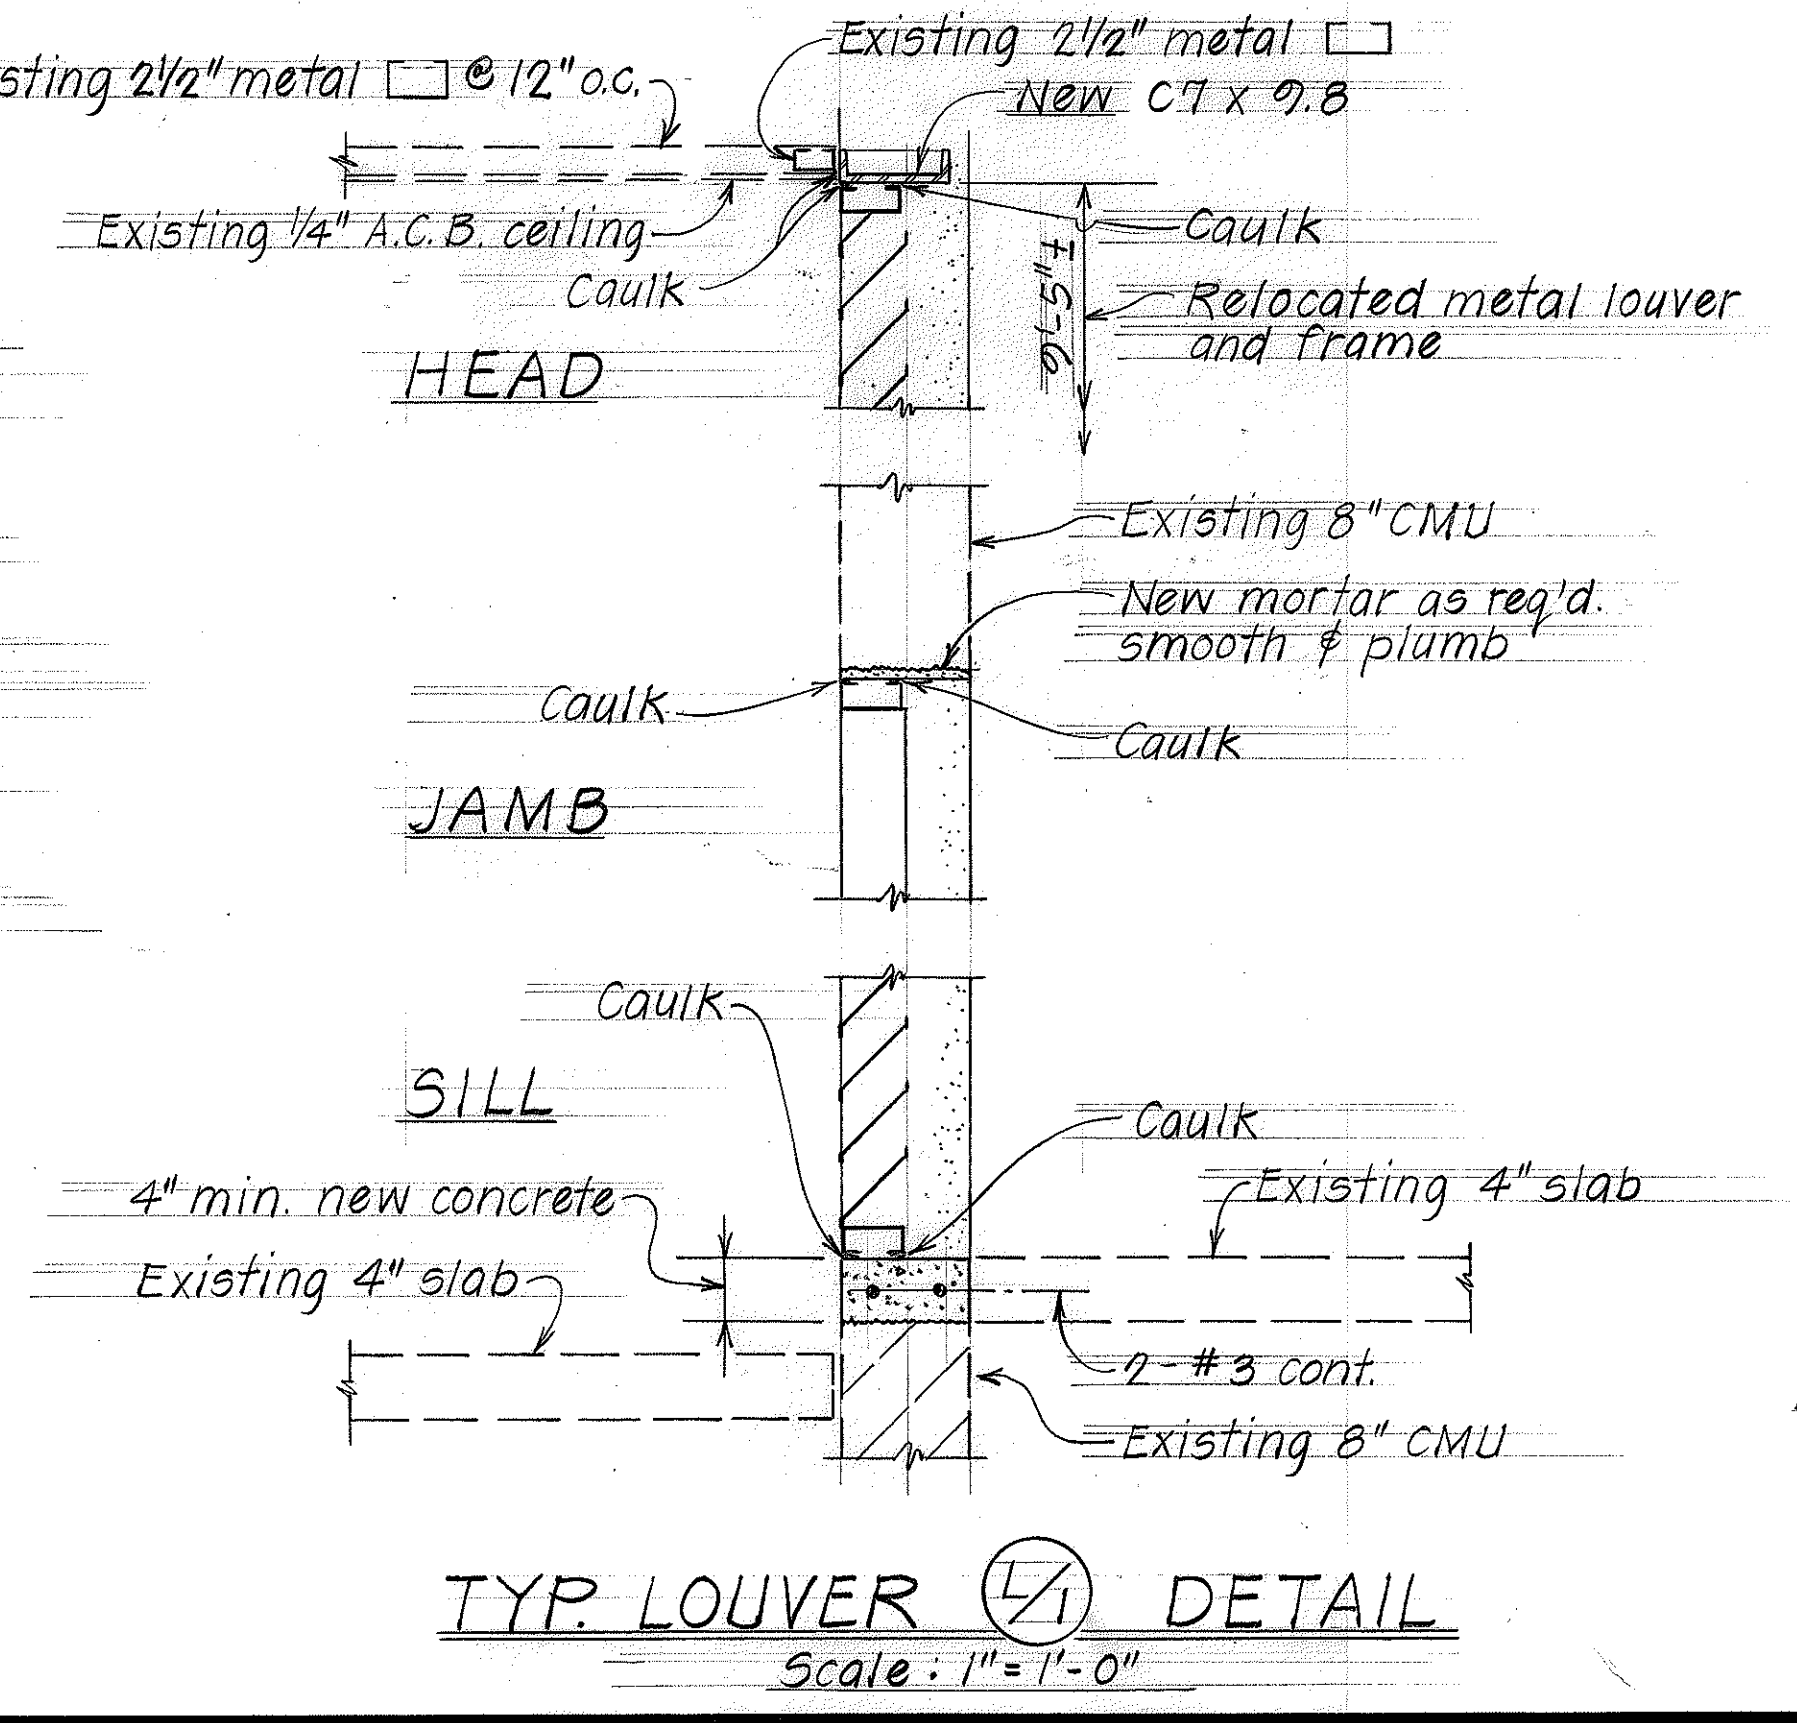
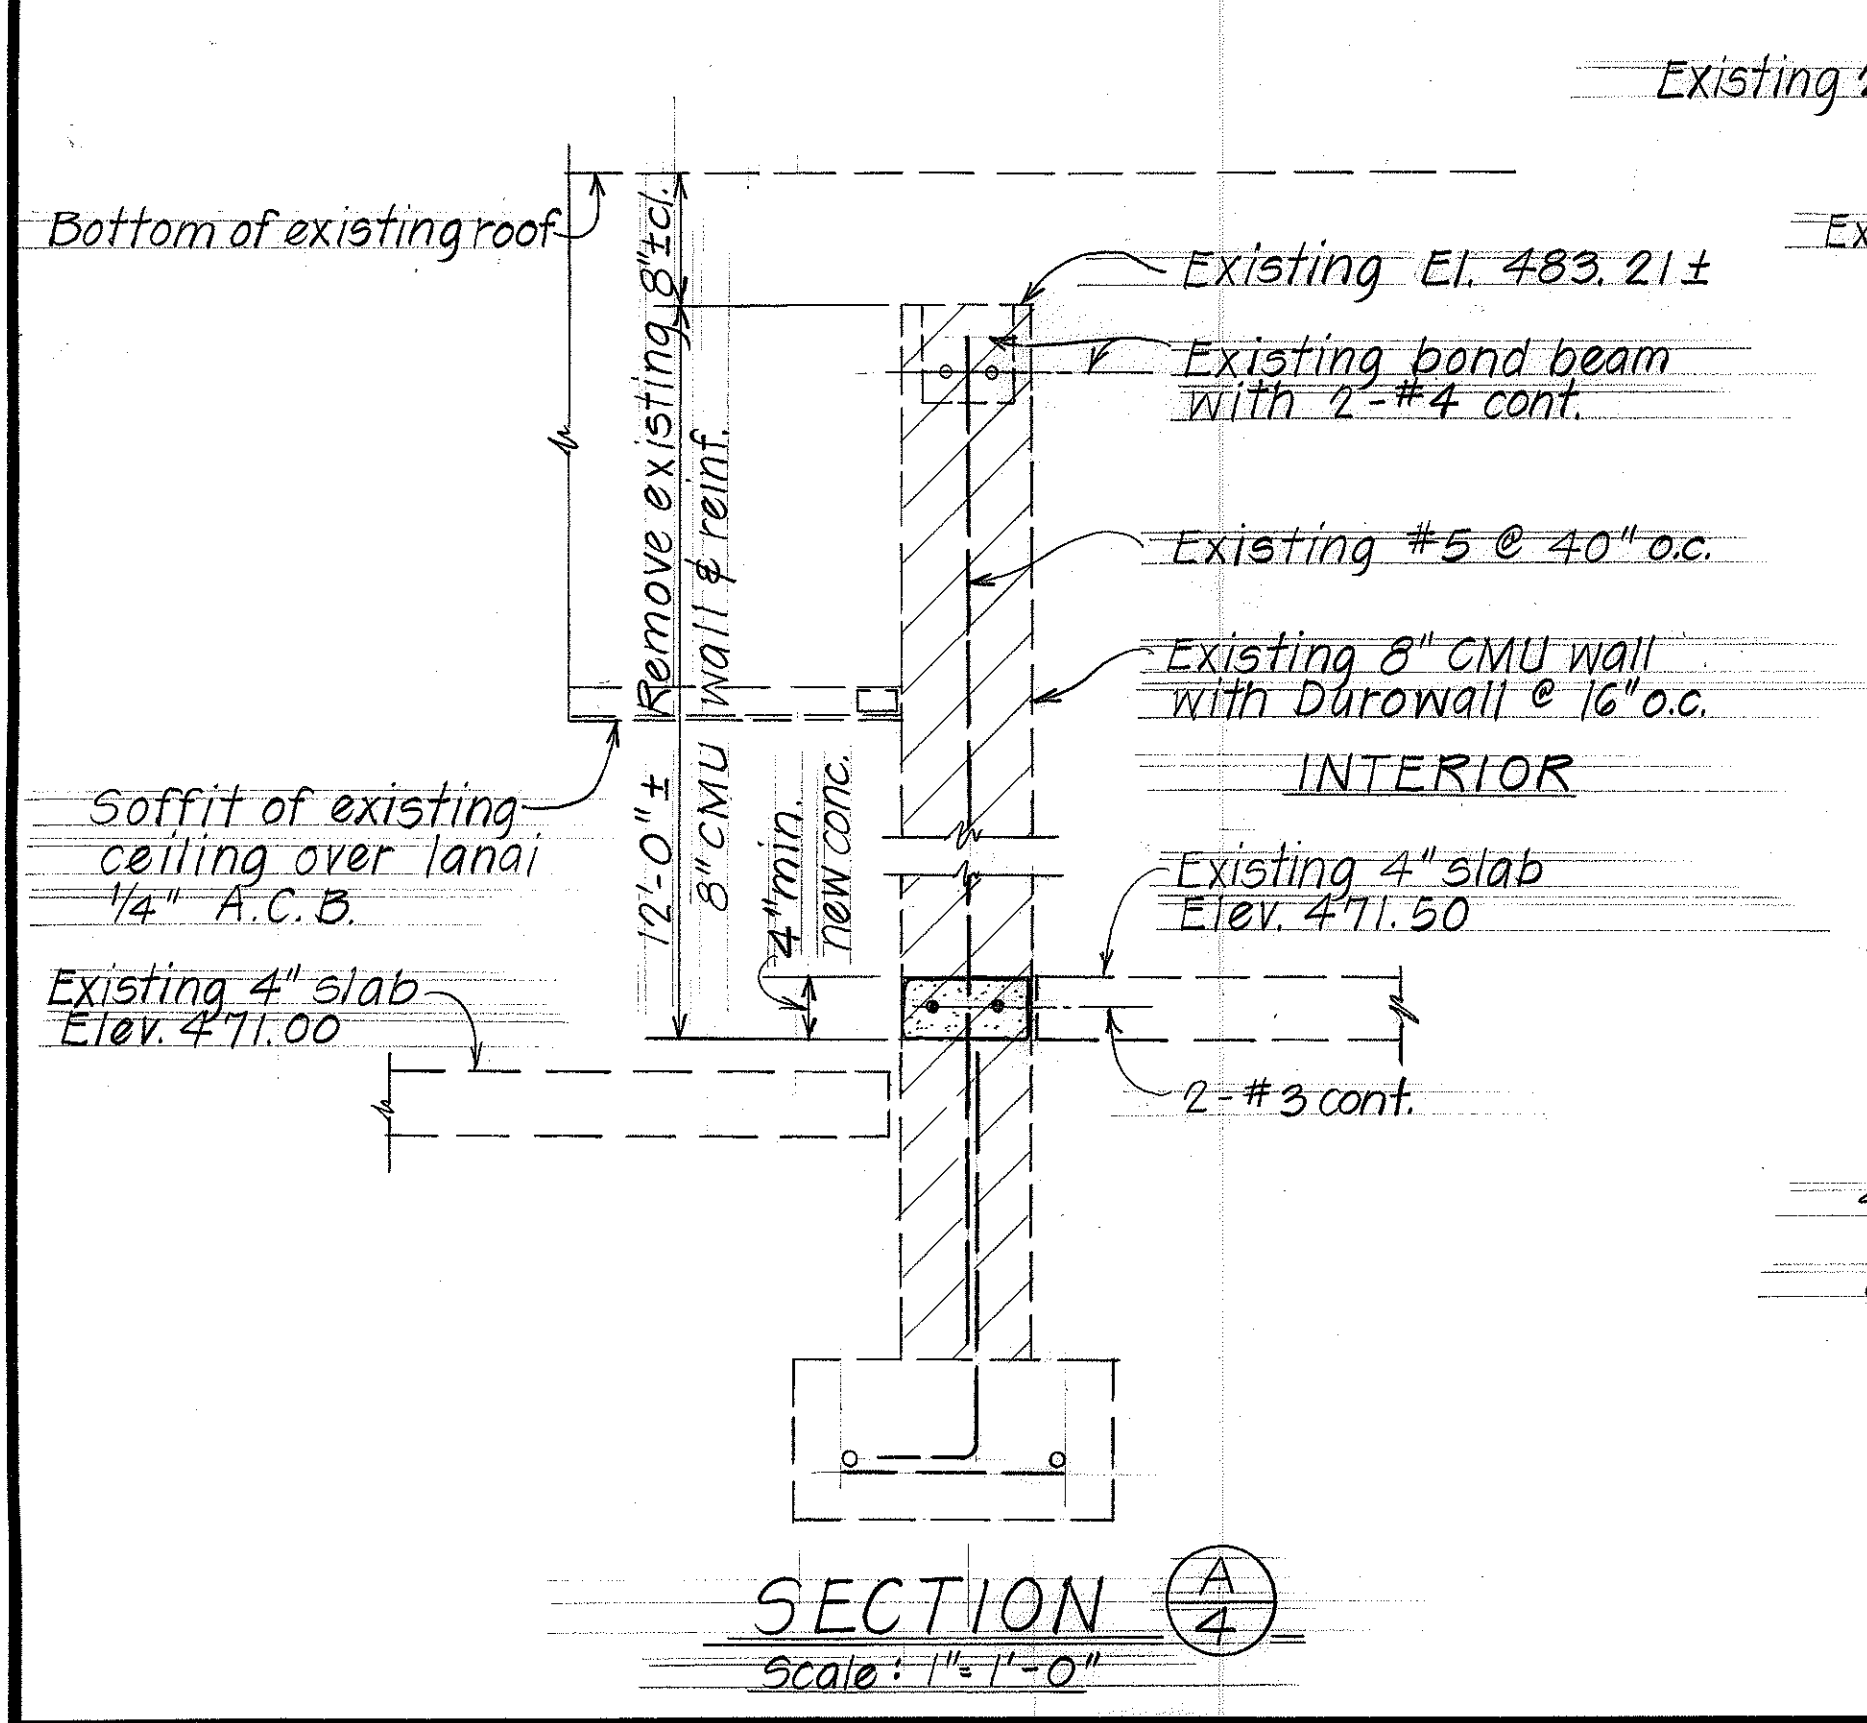
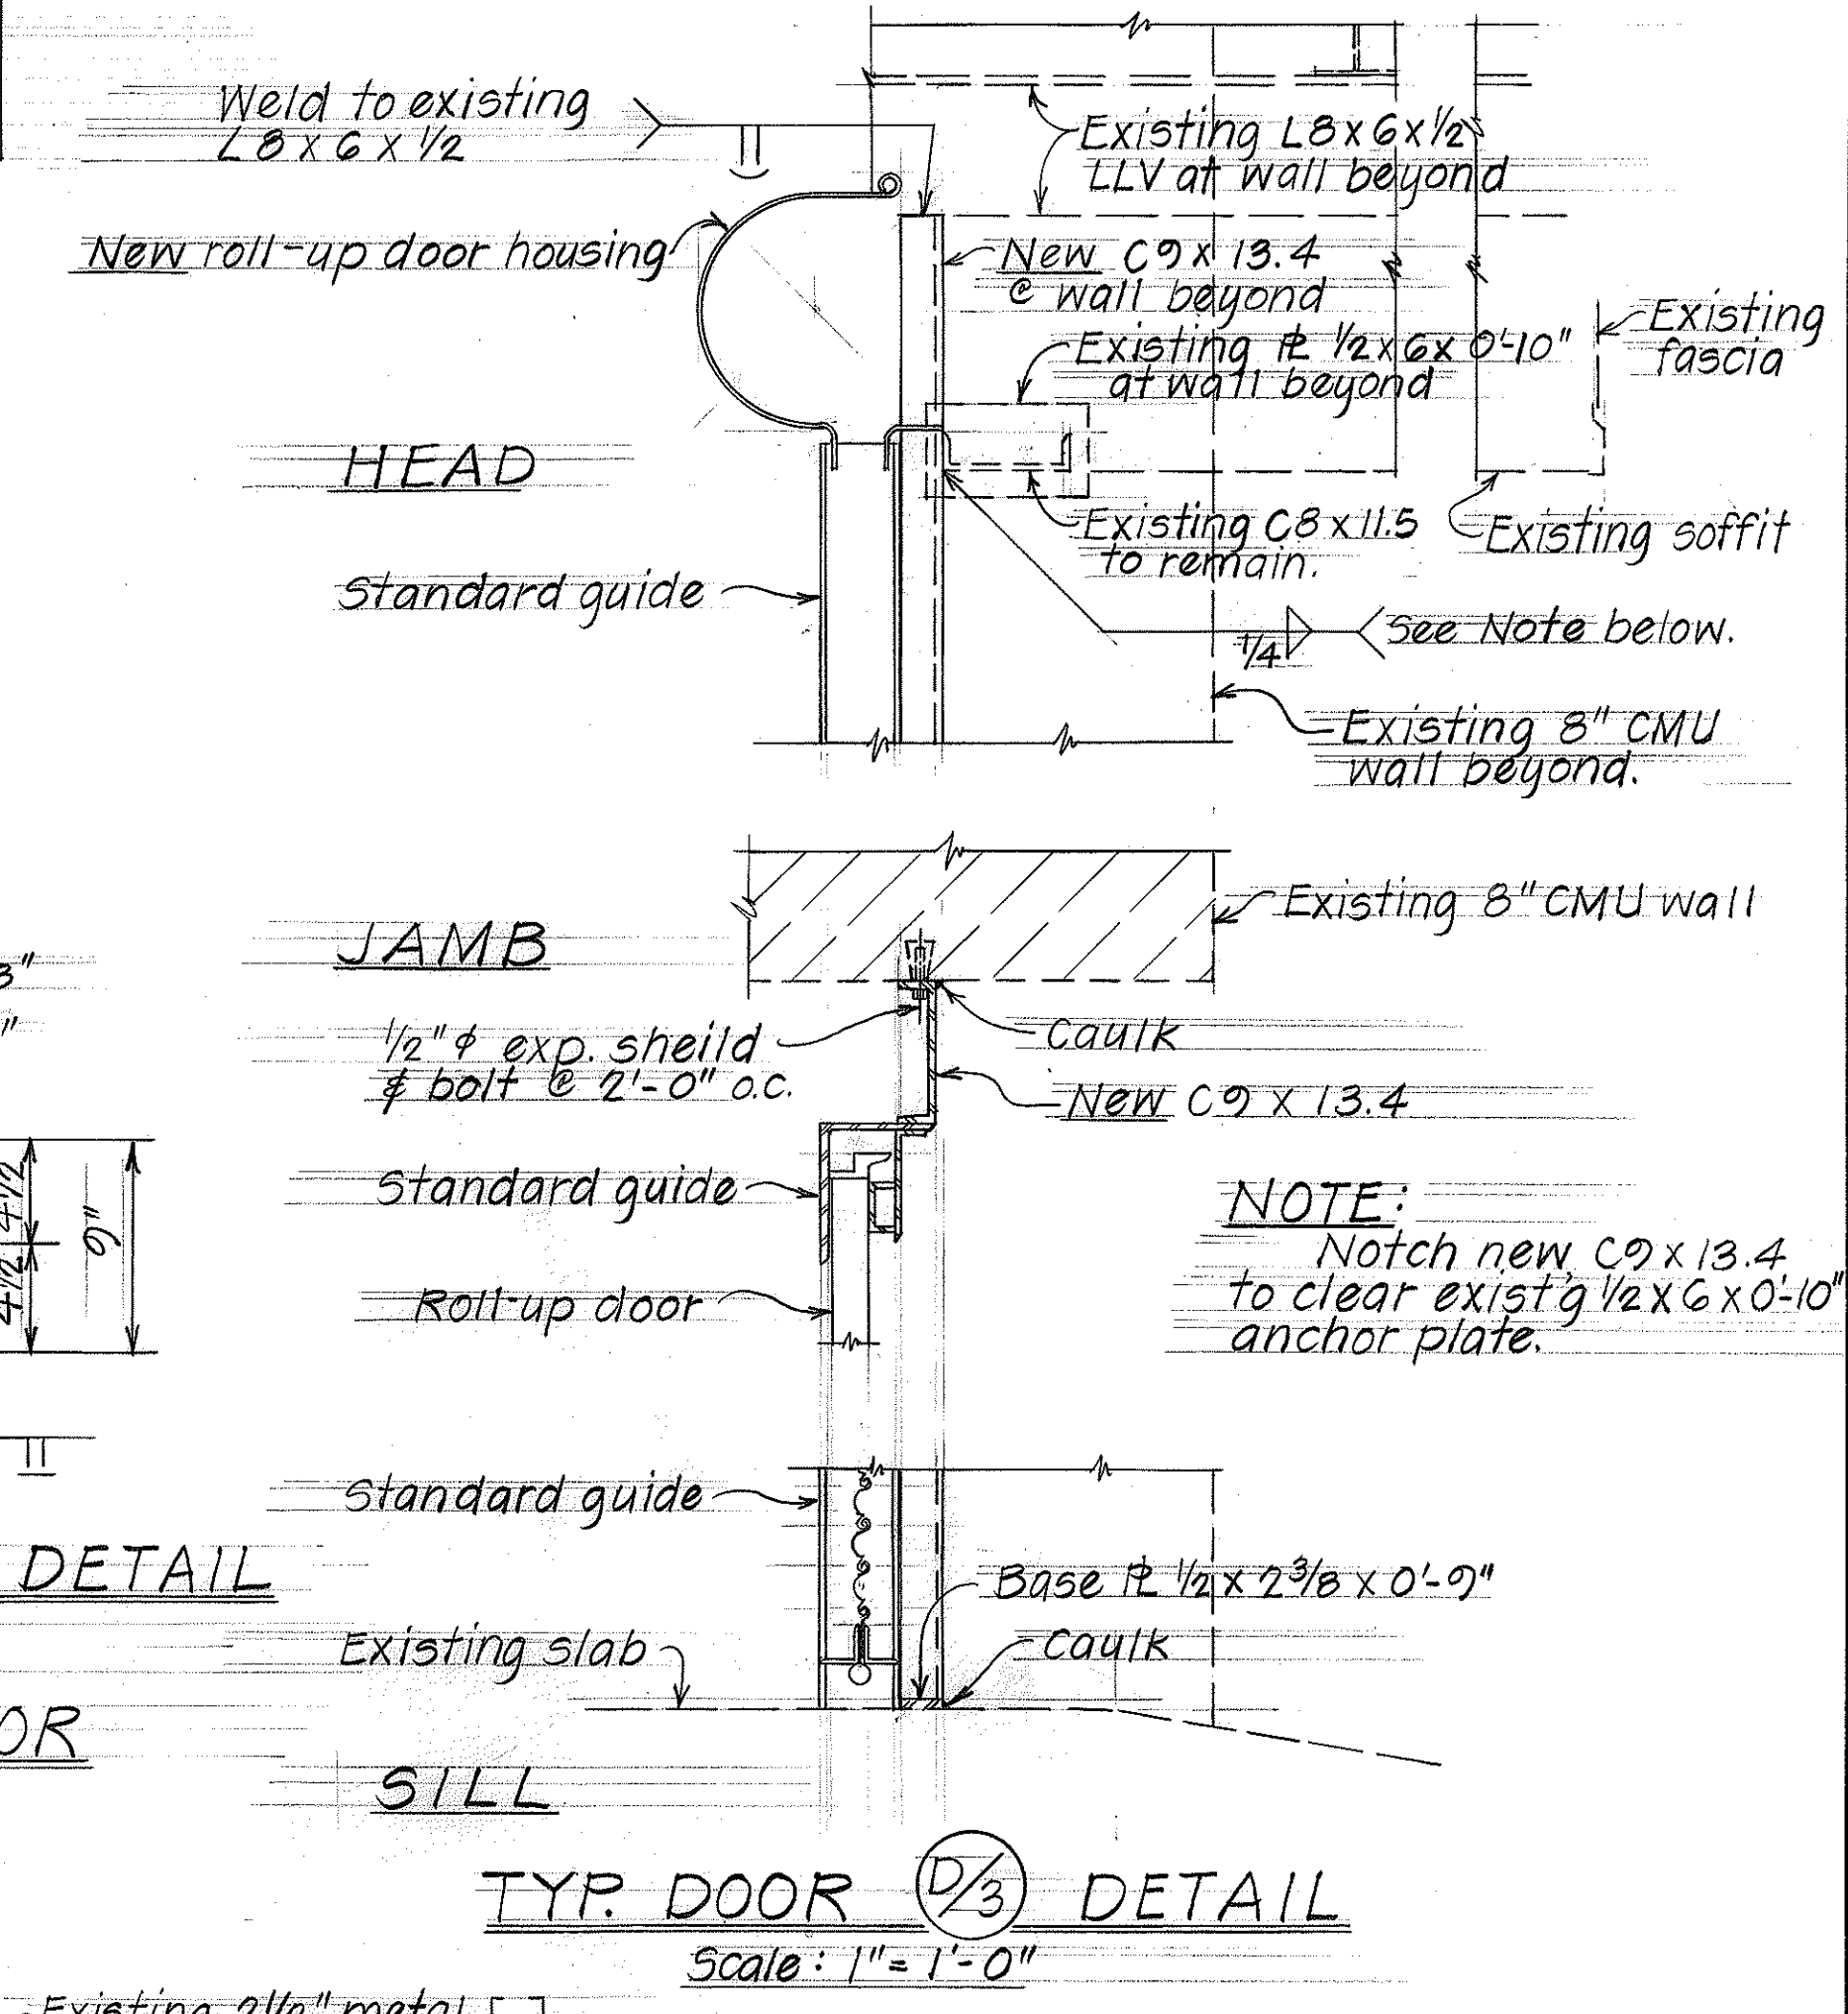
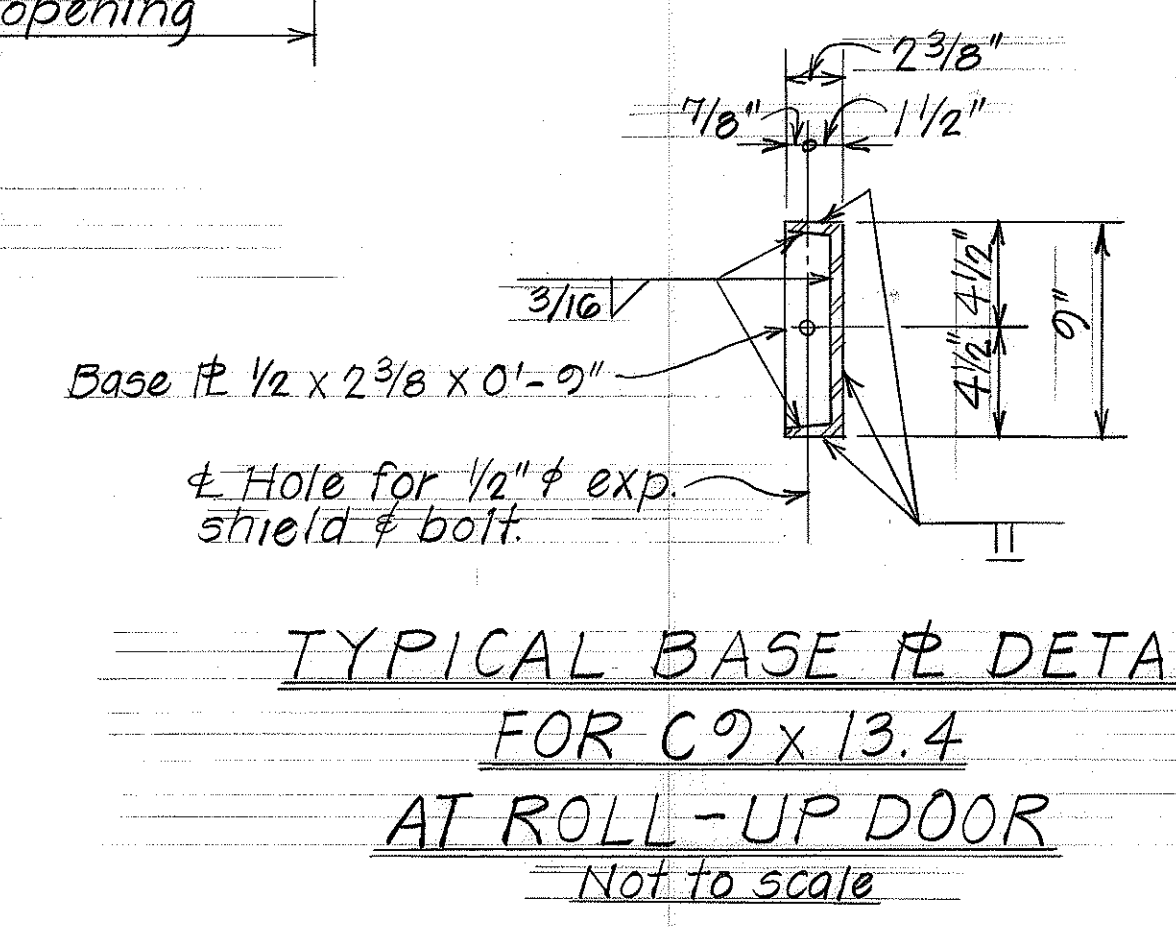


FED. ROAD DIST. NO.	STATE	PROJ. NO.	FISCAL YEAR	SHEET NO.	TOTAL SHEETS
HAWAII	HAW.	HWY-05-76	1979	5	6

LUMINAIRE SCHEDULE			
TYPE	LAMP DATA	MANUFACTURER	DESCRIPTION
A-440	4-40W R.S.-C.W	Daybrite Luvex-4R Sylvania Tartan Series	Ceiling fluorescent 25"x35" metal louvers, metal sides, baked white enamel on 20 ga. steel chassis and ends, no light leaks at corners or edges of fixtures. Surface mounting. Provide baked white enamel top reflector. A sound rated ballasts.

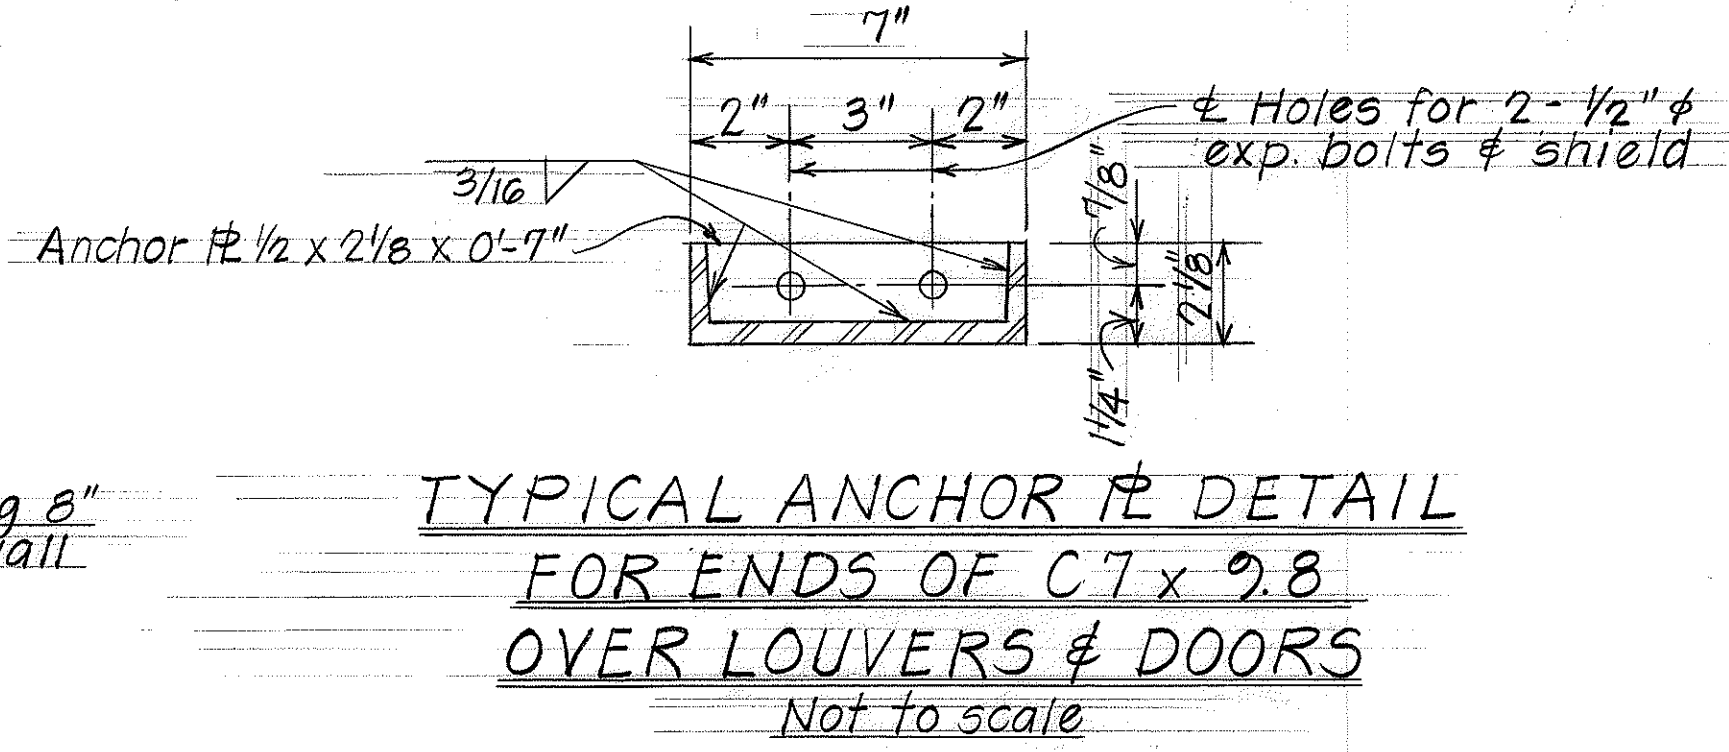

NOTE:
Existing lighting fixtures shall be removed and salvaged, and shall remain the property of the State.

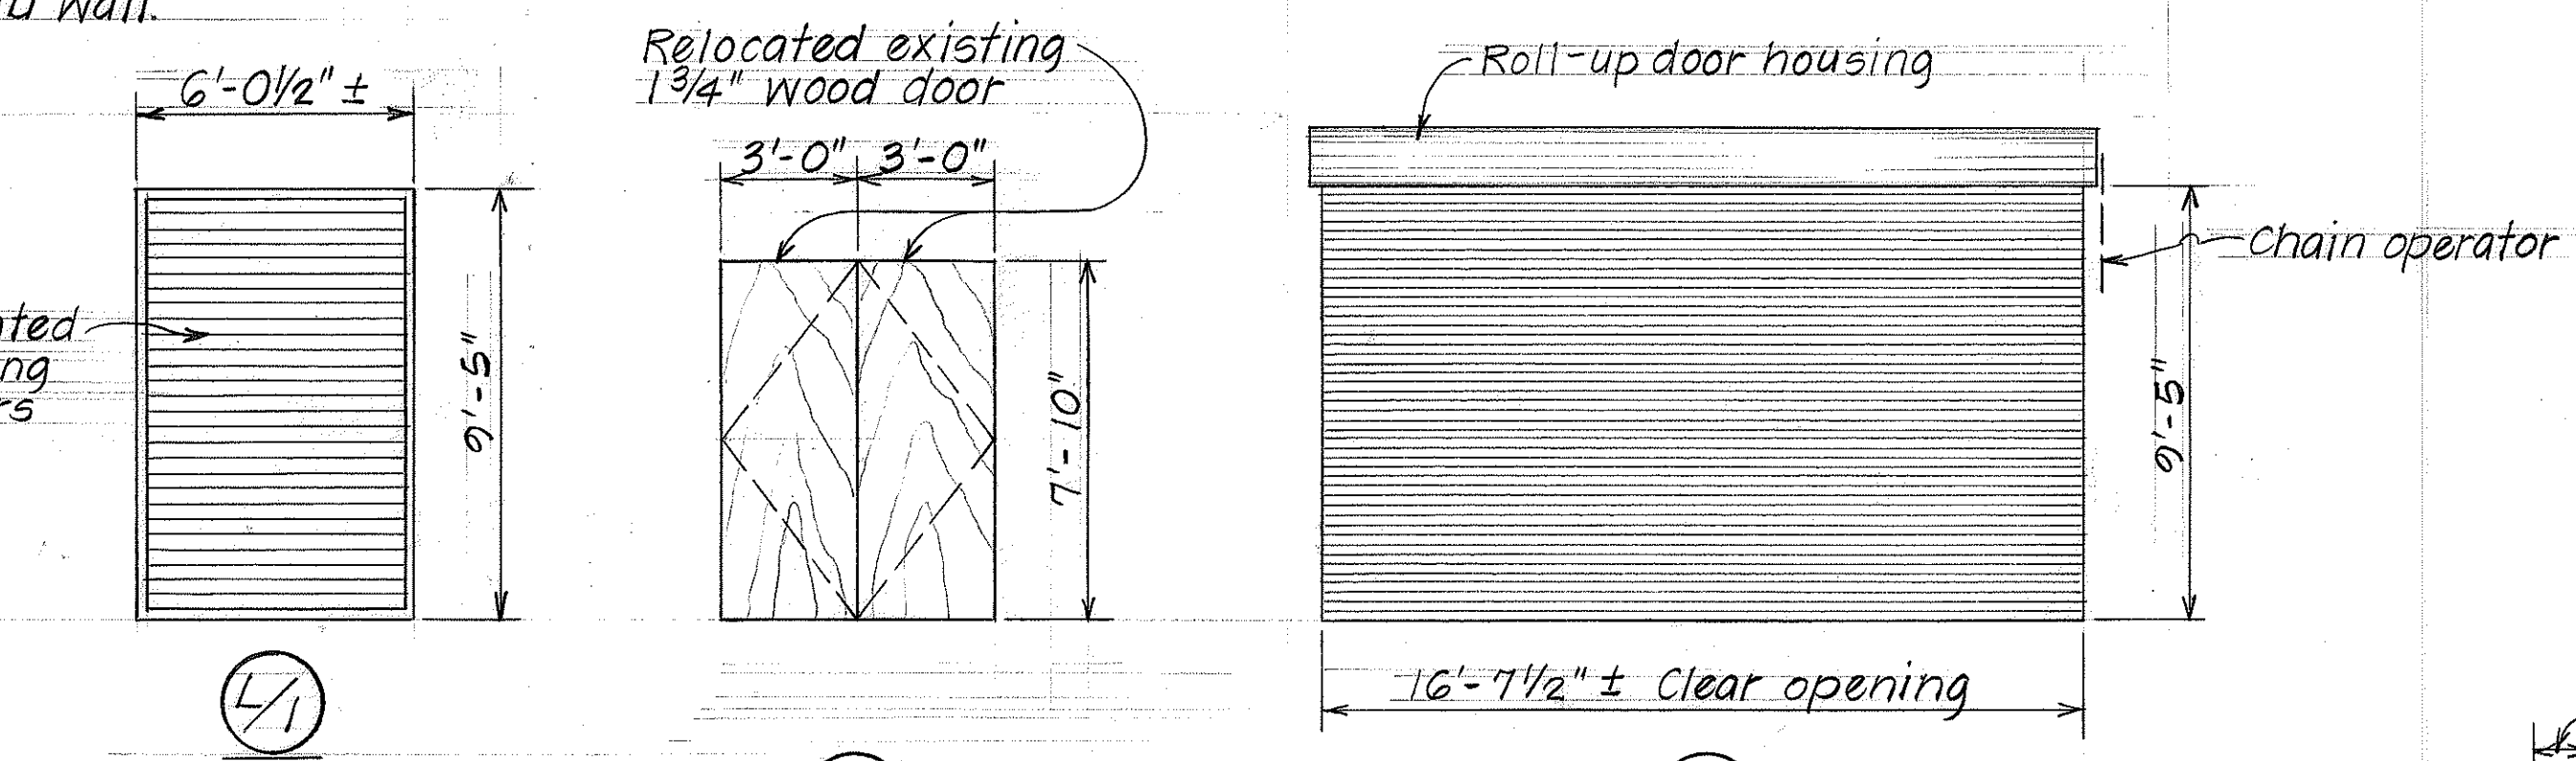

STATE OF HAWAII

DEPARTMENT OF TRANSPORTATION

LAND TRANSPORTATION FACILITIES DIVISION

EQUIPMENT CALIBRATION FACILITY

MATERIALS LABORATORY

PROJ. NO. HWY-0-05-76

Scale: As Noted Date: March 1979

SHEET NO. 4 OF 5 SHEETS

SURVEY PLOTTED BY	DATE
DRAWN BY L.M.A.	3/74
DESIGNED BY E.N.	3/74
CHECKED BY L.A.	3/74
ORIGINAL PLAN	
NOTE BOOK	