


FED. ROAD DIST. NO.	STATE	FED. AID PROJ. NO.	FISCAL YEAR	SHEET NO.	TOTAL SHEETS
HAWAII	HAW.	HWY-0-08-91	1991	2	4

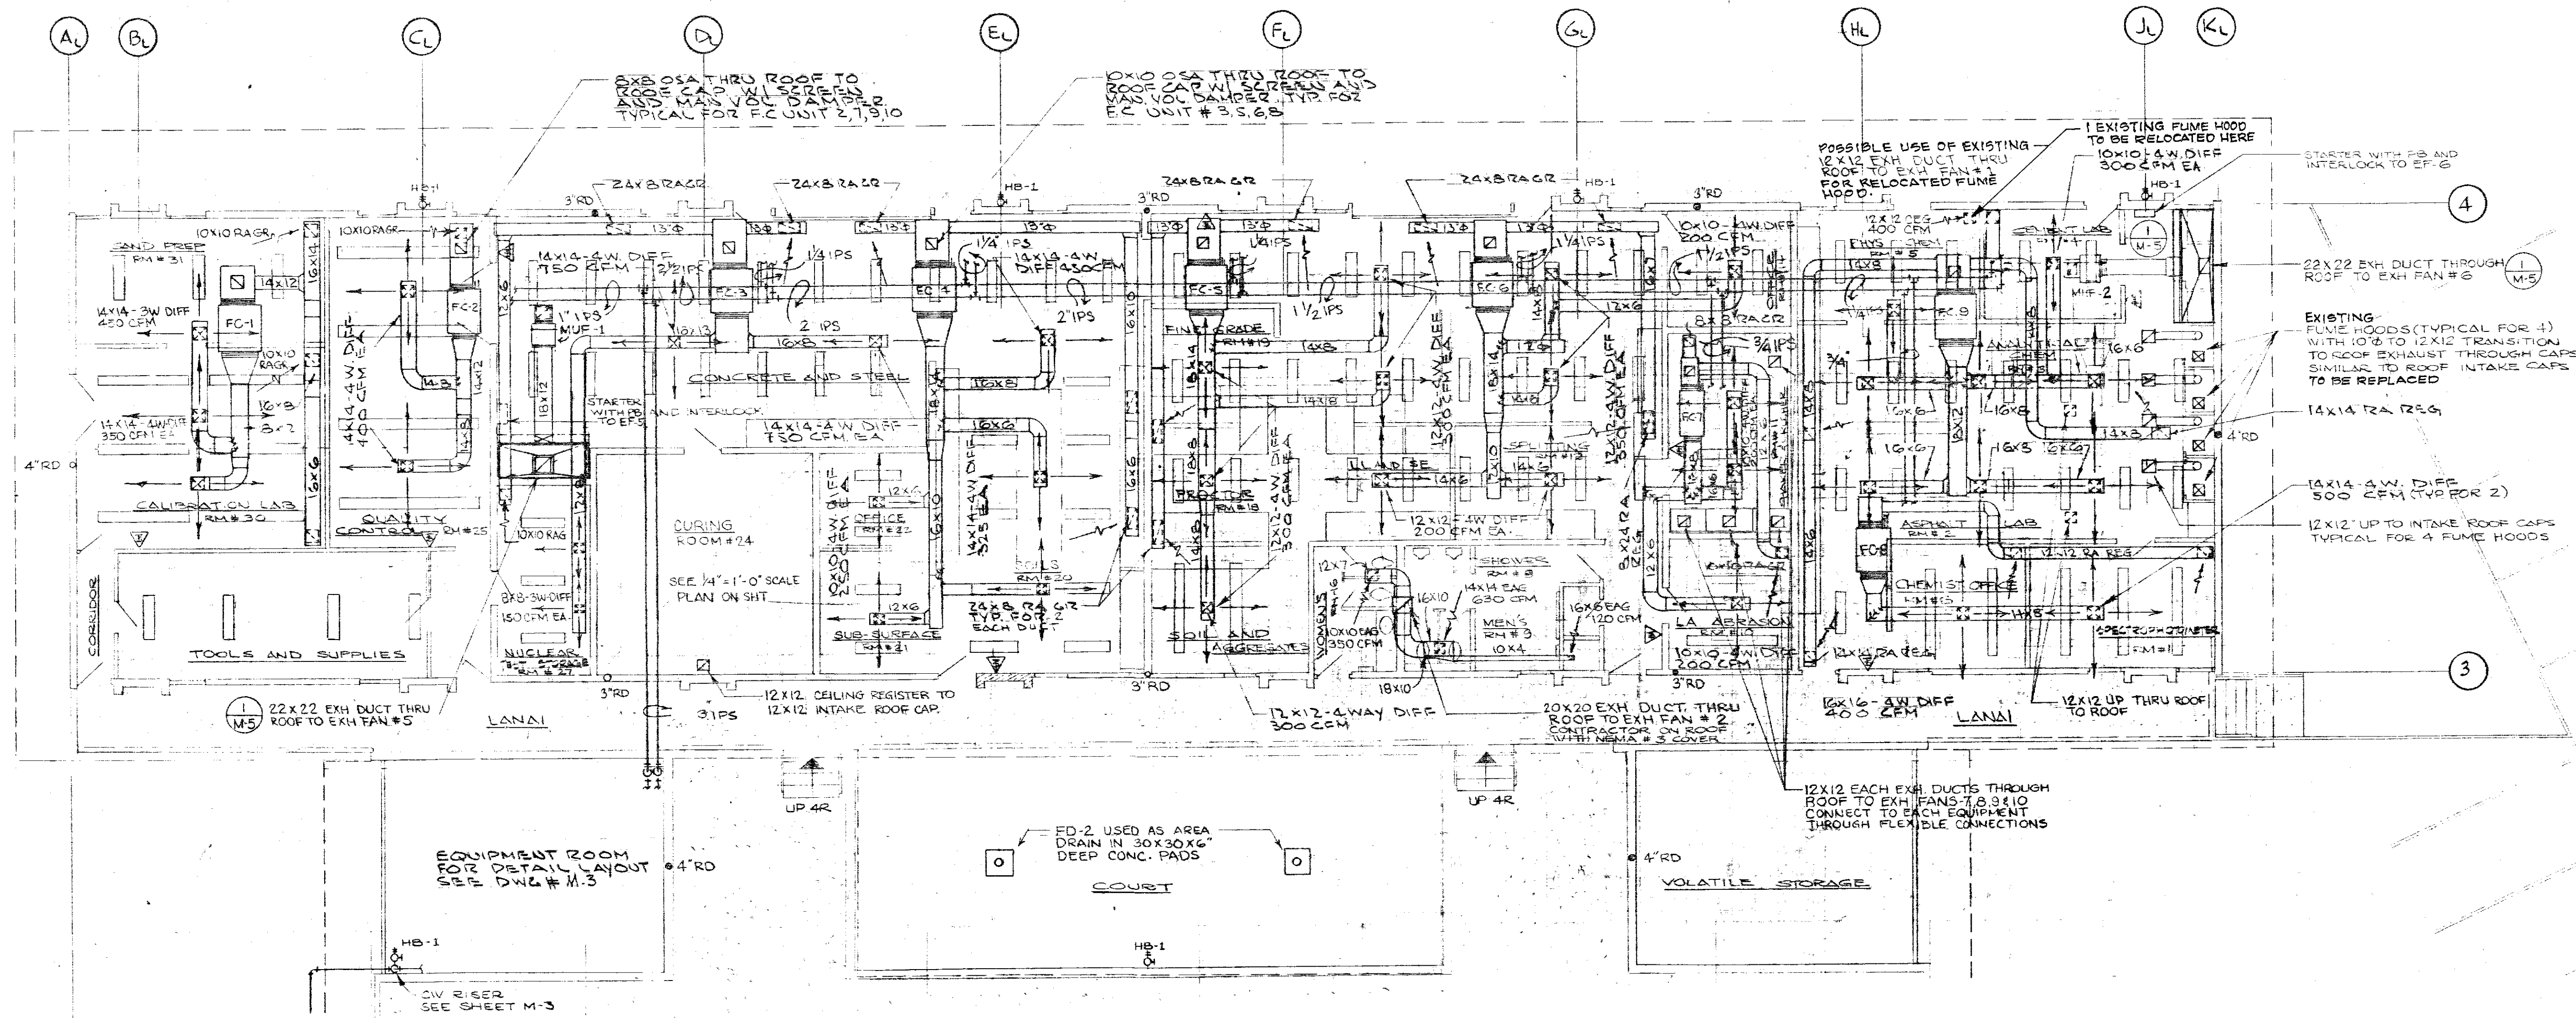

DATE	_____
SURVEY PLOTTED BY	_____
DRAWN BY	_____
DESIGNED BY	_____
CHECKED BY	_____
ORIGINAL PLAN	_____
NOTE BOOK	_____
NO.	_____

STATE OF HAWAII
DEPARTMENT OF TRANSPORTATION
HIGHWAYS DIVISION

PARTIAL A/C AND VENTILATION PLAN

MATERIAL TESTING LABORATORY

Replace Fume Hoods in Chemical Laboratory

PROJECT NO. HWY-0-08-91

Scale: As Noted Date: _____

SHEET No. 1 OF 1 SHEETS